





INDEX

DESCRIPTION	LOCATION	SHT. NO.	DESCRIPTION	LOCATION	SHT. NO.
Title Sheet		1	Copper Ave. N.E. (Elm St. to Pine St.)		11
Location Map		2	Locust St. N.E. (Copper Ave. to Grand Ave.)		11
Summary of Quantities		3	Lead Ave. S.E. (Maple St. to Ash St.)		11
Buena Vista Dr. S.E. (Stadium Blvd. to Bell Ave.)		4	Pine St. S.E. (Lead Ave. to Silver Ave.)		11
Willmore Dr. S.E. (Anderson Ave. to Stadium Blvd.)		4	Spruce St. N.E. (Central Ave. to Copper Ave.)		11
Yale Blvd. S.E. (Stadium Blvd. to Bell Ave.)		4	Tijeras Ave. N.E. (Ash St. to University Ave.)		11
Southern Ave. S.E. (Willmore Dr. to Yale Blvd.)		4	Ash St. S.E., N.E. (Silver Ave. to Copper Ave.)		11
Kathryn Ave. S.E. (Willmore Dr. to Yale Blvd.)		4	Sycamore St. S.E. (Silver Ave. to Gold Ave.)		11
Anderson Ave. S.E. (Willmore Dr. to Yale Blvd.)		4	Terrace St. S.E. (Silver Ave. to Gold Ave.)		11
			Buena Vista Dr. S.E. (Silver Ave. to Gold Ave.)		11
			Gold Ave. S.E. (Terrace St. to Buena Vista Dr.)		11
Smith Ave. S.E. (Stanford Dr. to Girard Blvd.)		5			
Thaxton Ave. S.E. (Stanford Dr. to Vassar Dr.)		5	Cedar St. N.E. (Copper Ave. to Tijeras Ave.)		12
Princeton Dr. S.E. (Thaxton Ave. to Smith Ave.)		5	Tijeras Ave. N.E. (Mulberry St. to Sycamore St.)		12
Vassar Dr. S.E. (Thaxton Ave. to Smith Ave.)		5	Spruce St. N.E. (Tijeras Ave. to Grand Ave.)		12
			Sycamore St. N.E. (Tijeras Ave. to Grand Ave.)		12
Smith Ave. S.E. (Cornell Dr. to Amherst Dr.)		6	Lead Ave. S.E. (Ash St. to Pine St.)		12
Anderson Ave. S.E. (Wellesley Dr. to Amherst Dr.)		6	Arno St. N.E. (Central Ave. to Copper Ave.)		12
Amherst Dr. S.E. (Thaxton Ave. to Smith Ave.)		6	Copper Ave. N.E. (Arno St. to Walter St.)		12
Vail Ave. S.E. (Amherst Dr. to Carlisle Blvd.)		6	Gold Ave. S.E. (Sycamore St. to Maple St.)		12
Eastern Ave. S.E. (Amherst Dr. to Carlisle Blvd.)		6	Sigma Chi Rd. N.E. (Spruce St. to Univ. Blvd.)		12
Carlisle Blvd. S.E. (Crest Ave. to Vail Ave.)		6			
Gibson Blvd. S.E. (West of University Ave.)		6	John St. S.E. (Gold Ave. to Central Ave.)		13
Cornell Dr. S.E. (Smith Ave. to Kathryn Ave.)		6	Gold Ave. S.E. (John St. to Broadway Blvd.)		13
			Silver Ave. S.E. (John St. to Broadway Blvd.)		13
Yale Blvd. S.E. (St. Cyr Ave. to Lead Ave.)		7	Copper Ave. N.E. (High St. to Elm St.)		13
St. Cyr Ave. S.E. (Buena Vista Dr. to Yale Blvd.)		7	Elm St. S.E. (Lead Ave. to Silver Ave.)		13
Buena Vista Dr. S.E. (Ross Ave. to Lead Ave.)		7	Lomas Blvd. N.E. (High St. to I-25)		13
Willmore Dr. S.E. (North of Ross Ave.)		7			
Anderson Dr. S.E. (Buena Vista Dr. to Yale Blvd.)		7	Ridge Pl. N.E. (Grand Ave. to Marquette Pl.)		14
Coal Ave. S.E. (West of Buena Vista Dr.)		7	Spruce St. N.E. (Grand Ave. to Las Lomas Rd.)		14
Lead Ave. S.E. (At Lead Ave. and Buena Vista Dr.)		7	Sycamore St. N.E. (Grand Ave. to Las Lomas Rd.)		14
Ash St. S.E. (South of Coal Ave.)		8	Roma Ave. N.E. (Spruce St. to Maple St.)		14
Hazeldine Ave. S.E. (Sycamore St. to University Ave.)		8	Marquette Pl. N.E. (Ridge Pl. to Spruce St.)		14
Pine St. S.E. (Hazeldine Ave. to Coal Ave.)		8	Ash St. N.E. (Grand Ave. to University Blvd.)		14
Coal Ave. S.E. (Hazeldine Ave. to Coal Ave.)		8			
University Blvd. S.E. (Coal Ave. to Hazeldine Ave.)		8	Oak St. N.E. (Alley N. of Roma Ave. to Las Lomas)		15
Sycamore St. S.E. (Hazeldine Ave. to Coal Ave.)		8	Cedar St. N.E. (Grand Ave. to Marquette Pl.)		15
			Roma Ave. N.E. (Oak St. to Encino Pl.)		15
Hazeldine Ave. S.E. (West of Oak St. to Cedar St.)		9	Mulberry St. N.E. (Marquette Pl. to Roma Ave.)		15
Oak St. S.E. (South of Coal Ave.)		9	Las Lomas Rd. N.E. (East of Oak St.)		15
Mulberry St. S.E. (Hazeldine Ave. to Coal Ave.)		9	Alley (N. of Roma N.E.) (Oak St. to Encino Pl.)		15
Cedar St. S.E. (Hazeldine Ave. to Coal Ave.)		9			
Coal Ave. S.E. (Mulberry St. to East of Cedar St.)		9	Cedar St. N.E. (Roma Ave. to Las Lomas Rd.)		16
			Las Lomas Rd. N.E. (Cedar St. to Ridge Pl.)		16
Mesa St. S.E. (Gold Ave. to Central Ave.)		10	Ridge Pl. N.E. (South of Las Lomas Rd.)		16
Lead Ave. S.E. (Spruce St. to Maple St.)		10	Med - Art Ave. N.E. (Lomas Blvd. to Encino Pl.)		16
Maple St. S.E. (Hazeldine Ave. to Central Ave.)		10	Roma Ave. N.E. (Commercial St. to Broadway Blvd.)		17
Coal Pl. S.E. (East of Mesa St.)		10	John St. N.E. (Roma Ave. to Lomas Blvd.)		17
Coal Ave. S.E. (Oak St. to Spruce St.)		10			
Elm St. S.E. (Coal Ave. to Lead Ave.)		10	Details		18
Oak St. S.E. (Coal Ave. to Lead Ave.)		10			
Mulberry St. S.E. (Coal Ave. to Lead Ave.)		10			
Spruce St. S.E. (Coal Ave. to Silver Ave.)		10			
Locust St. S.E. (Gold Ave. to Silver Ave.)		10			

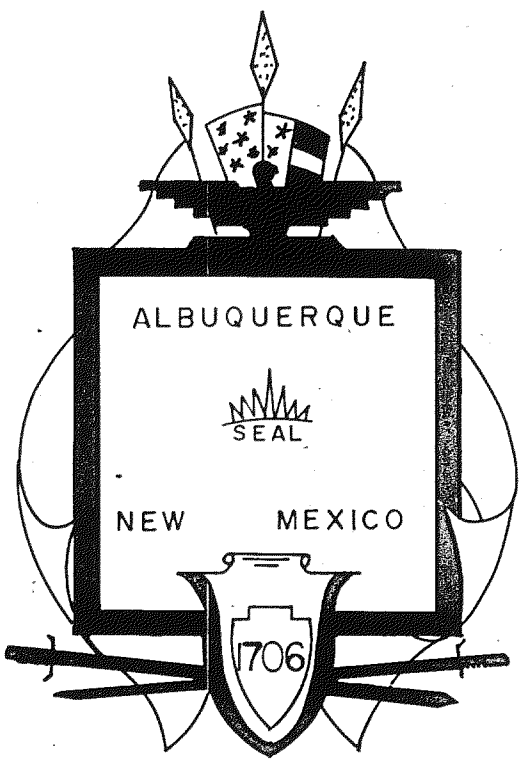


CITY OF ALBUQUERQUE, NEW MEXICO
MUNICIPAL DEVELOPMENT DEPARTMENT

 SIDEWALK AND CURB & GUTTER
IMPROVEMENT DISTRICT NO. 5

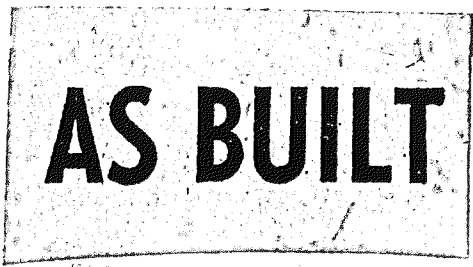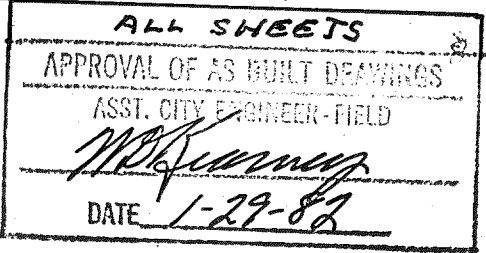

GARDNER ENGINEERS, INC.
ALBUQUERQUE, NEW MEXICO

SET NO. _____
DATE _____

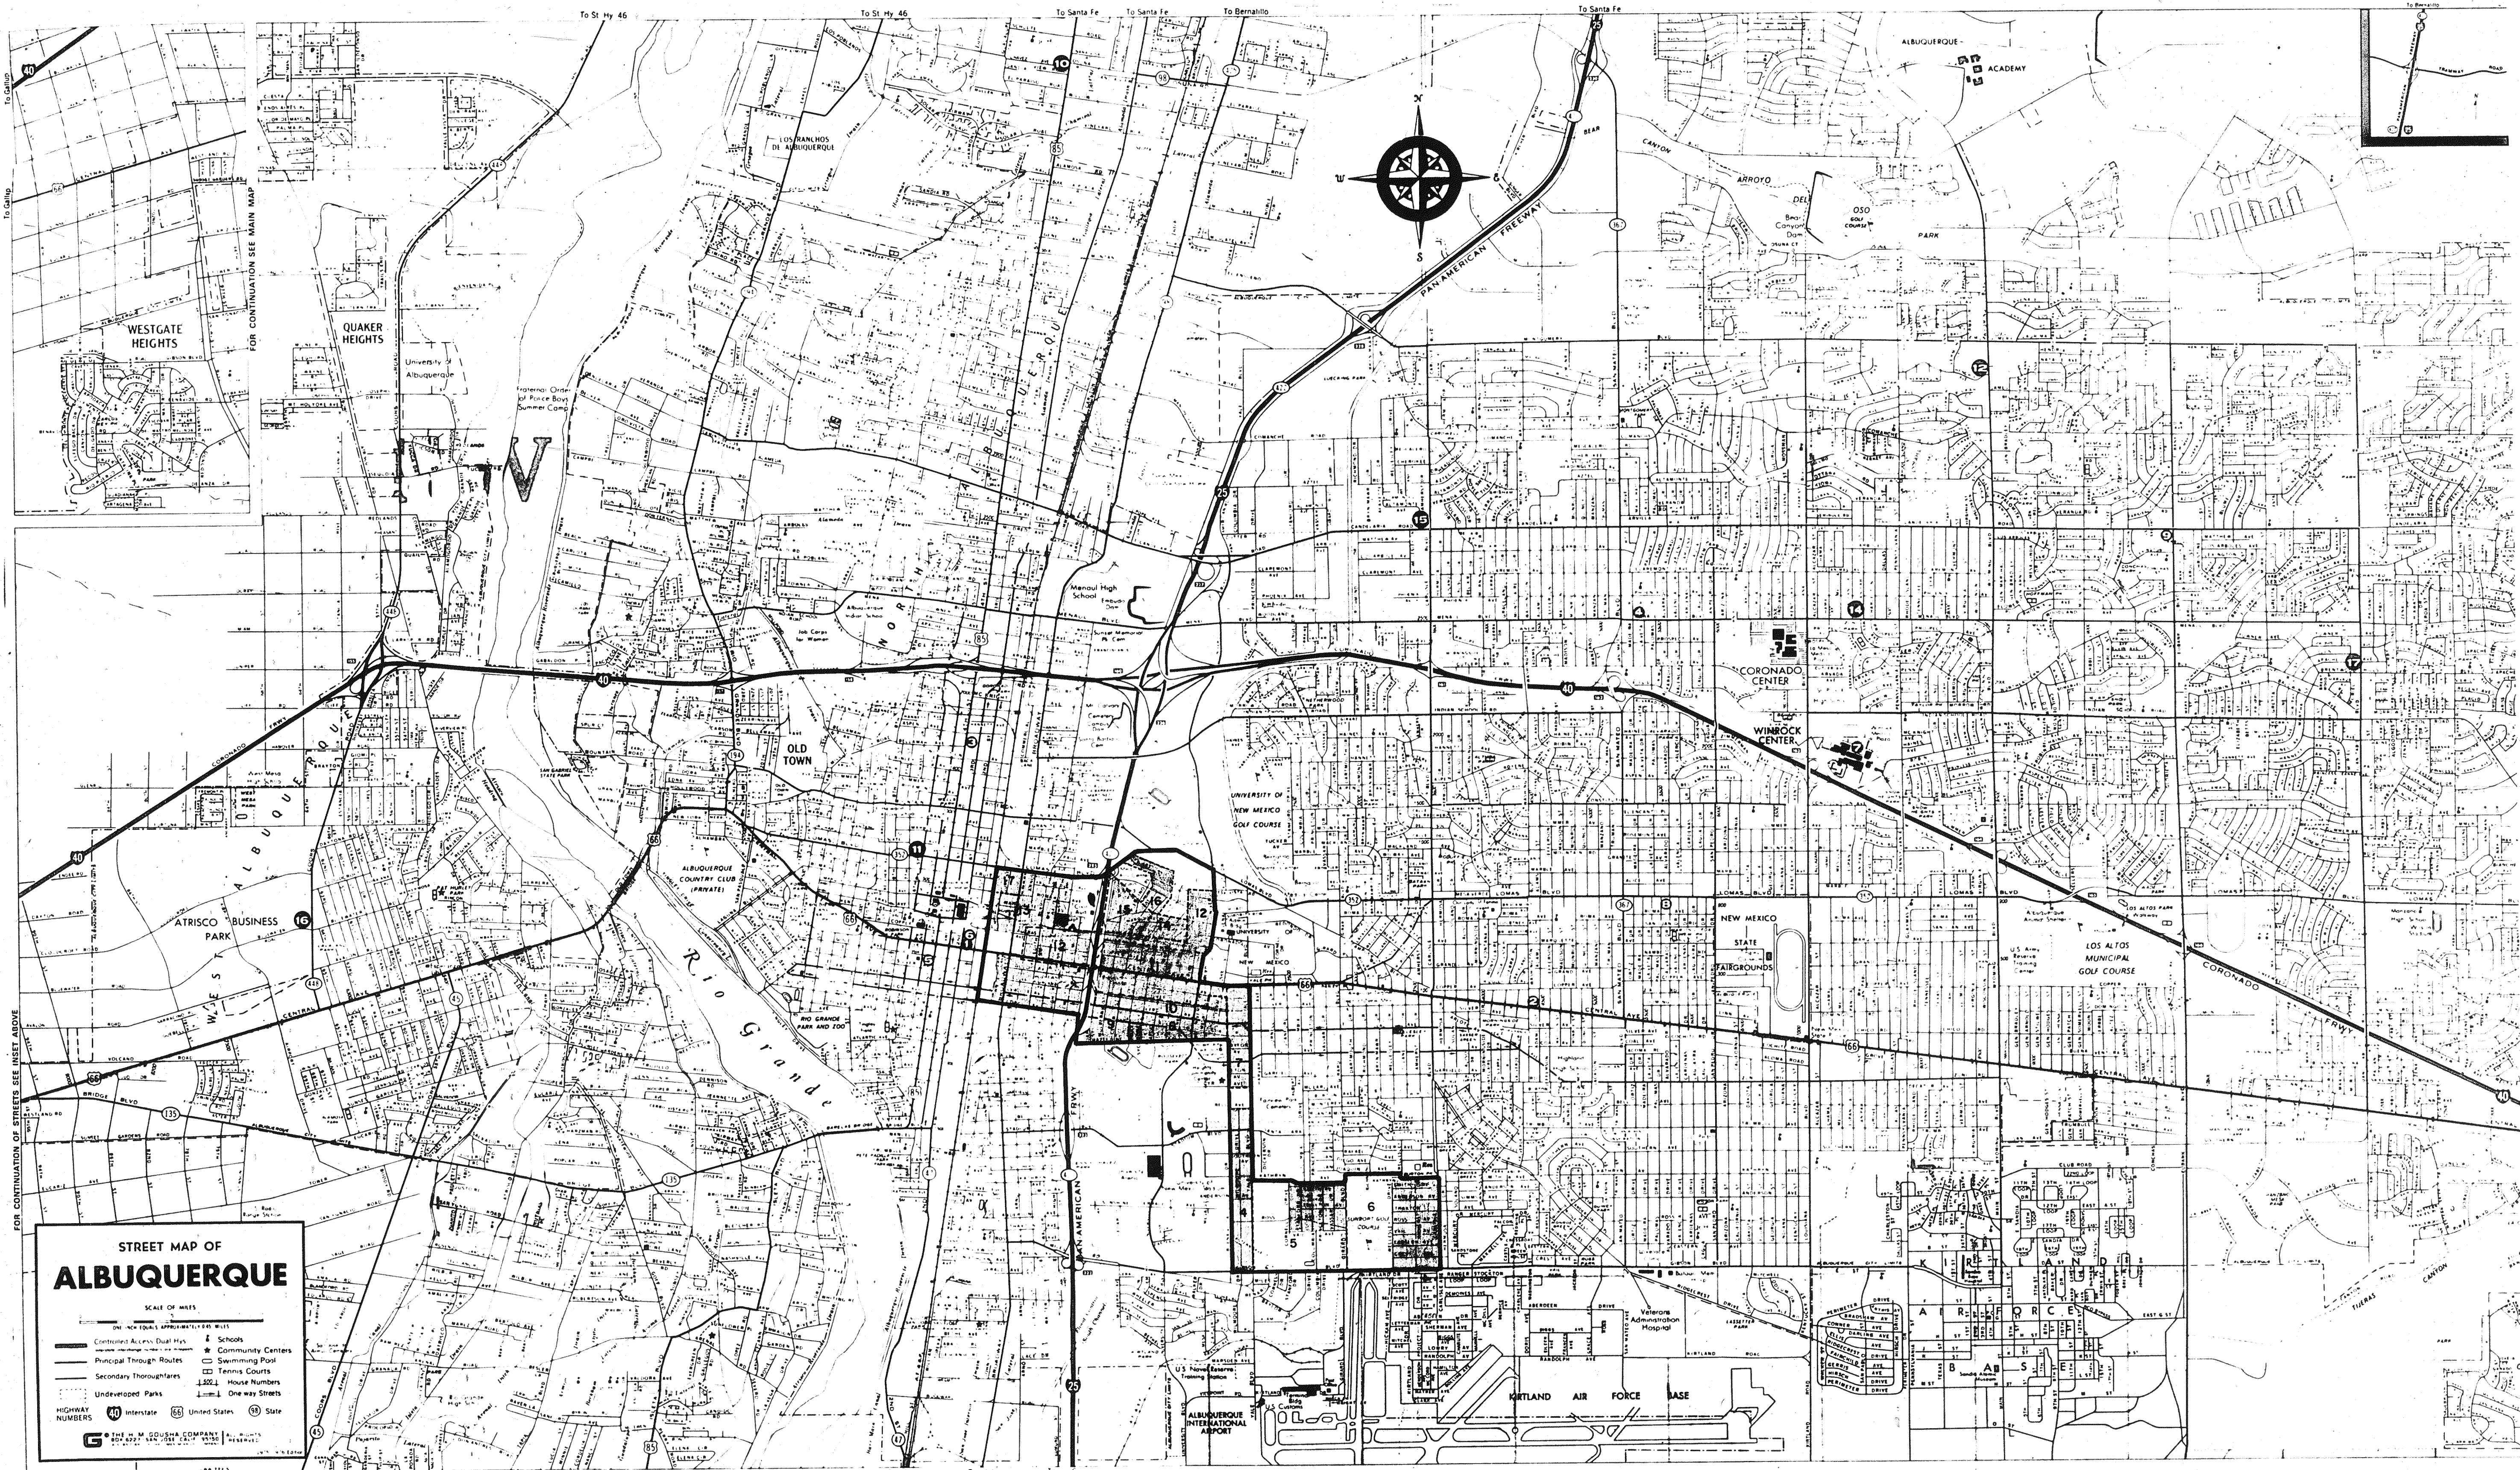

SHADING INDICATES AREAS OF PROPOSED SIDEWALK CONSTRUCTION
NUMBERS INDICATE SHEET NUMBERS

LOCATION MAP CITY OF ALBUQUERQUE

1" = 0.45 miles (approx.)
0 1/2 mi. 1 mi.

AS BUILT



GARDNER ENGINEERS, INC.
ALBUQUERQUE, NEW MEXICO

1 2 3 4 5 6 7 8 9 10 11 12
10 001 0282



CITY OF ALBUQUERQUE MUNICIPAL DEVELOPMENT DEPARTMENT ENGINEERING DIVISION					
TITLE SIDEWALK & CURB & GUTTER IMPROVEMENT DISTRICT NO. 5 LOCATION MAP					
APPROVALS	ENGINEER	DATE	APPROVALS	ENGINEER	DATE
City Engineer			Liquid Waste		
A.C.E. Design			Traffic		
A.C.E. Hydrology			Water		
DRAWING NO.			SHEET 2 OF 18		


CONTRACTOR		DATE	
Work	1/18/81	By	
Accepted By		DATE	
Drawing		By	
REVISIONS	DATE		
NO.	DATE	BY	DATE
1			
2			
3			
100			


SECT. NO.	ITEM NO.	I T E M	UNIT OF MEASURE	GRAND TOTAL	
				ESTIMATE	FINAL
	1	CLEARING AND GRUBBING	L.S.	L.S.	L.S.
	2	UNCLASSIFIED EXCAVATION	C.Y.	640	795
	3	EMBANKMENT	C.Y.	135	87
	4	4" CONCRETE SIDEWALK INCLUDING SUBBASE AND SUBGRADE PREP.	S.Y.	9400	5528
	5	SPECIAL BRICK SIDEWALKS INCLUDING SUBBASE & SUBGRADE PREP.	S.Y.	1200	75
	6	STANDARD CONCRETE CURB & GUTTER INCLUDING SUBGRADE	L.F.	1682	1336
	7	CONCRETE DRIVEWAY GUTTERS INCLUDING SUBGRADE PREP.	L.F.	773	63640
	8	6" CONCRETE DRIVEPADS, INCLUDING SUBGRADE PREPARATION	S.Y.	2050	1200
	9	REINF. CONCRETE FOR STEPS AND DRAINS	C.Y.	9.1	5
	10	GRATED METAL DRAIN COVERS, COMPLETE IN PLACE	S.F.	43	41.10
	11	REMOVAL AND DISPOSAL OF EXISTING CONCRETE CURB & GUTTER	L.F.	2320	1982.50
	12	CUTTING, REMOVAL & DISPOSAL OF EXISTING ASPHALT PAVEMENT	S.Y.	860	552.90
	13	CUTTING, REMOVAL & DISPOSAL OF EXISTING CONCRETE SIDEWALK OR DRIVEPAD	S.Y.	675	531.80
	14	METER BOX REHABILITATION AND ADJUSTMENT TO GRADE	EA.	22	8
	15	WATER METER RELOCATION	EA.	97	34
	16	REMOVAL AND REPLACEMENT OF IRRIGATION WATER LINE	L.F.	500	0
	17	REMOVAL OF IRRIGATION SPRINKLERS, RISERS AND CAPPING OUTLETS	EA.	35	30
	18	FIRE HYDRANT EXTENSIONS (6" OR 12" LENGTH)	EA.	5	0
	19	ADJUSTING MANHOLE FRAMES AND COVERS TO GRADE	EA.	2	0
	20	ADJUSTING CLEANOUTS TO GRADE	EA.	2	1
	21	ADJUSTING VALVE BOXES TO GRADE	EA.	2	0
	22	RELOCATING EXISTING PICKET FENCE	L.F.	42	0
	23	RELOCATING EXISTING CHAIN LINK FENCE	L.F.	160	0
	24	REMOVAL AND DISPOSAL OF EXISTING RETAINING WALLS	S.F.	135	20
	25	REMOVAL AND DISPOSAL OF EXISTING CONCRETE STRUCTURES	C.Y.	11.0	3.39
	26	TRIMMING TREES AND SHRUBS	EA.	12	1
	27	REMOVAL AND DISPOSAL OF TREES	EA.	9	1
	28	REMOVAL AND DISPOSAL OF SHRUBS AND YUCCA	EA.	20	0
	29	REMOVAL AND DISPOSAL OF TREE STUMPS	EA.	4	3
	30	REMOVAL OF PARKING BUMPERS	EA.	26	23
	31	REMOVAL OF STEEL AND WOODEN POSTS	EA.	20	13
	32	REMOVAL OF LANDSCAPING ROCK	C.Y.	20	3
	33	ASPHALT PAVEMENT REPLACEMENT	S.Y.	90	28
	34	RELOCATING EXISTING UTILITY LINE LESS THAN 2" DIA	L.F.	150	0
		ALTERNATE A			
	A-1	REINFORCEMENT CONCRETE FILLED BLOCK RETAINING WALL	S.F.	3540	1660.68
	A-2	FOOTING FOR CONCRETE FILLED BLOCK RETAINING WALL	C.Y.	86	36.87
		ALTERNATE B			
	B-1	REINFORCEMENT CONCRETE RETAINING WALL	S.F.	3540	0
	B-2	FOOTING FOR CONCRETE RETAINING WALL	C.Y.	86	0

A circular professional engineer seal. The outer ring contains the text "RICHARD MASON" at the top and "REGISTERED PROFESSIONAL ENGINEER" at the bottom. The inner ring contains "NEW MEXICO" at the top and the license number "6686" in the center.

CITY OF ALBUQUERQUE MUNICIPAL DEVELOPMENT DEPARTMENT ENGINEERING DIVISION					
TITLE SIDEWALK & CURB & GUTTER IMPROVEMENT DISTRICT NO. 5					
SUMMARY OF QUANTITIES					
APPROVALS	ENGINEER	DATE	APPROVALS	ENGINEER	DATE
City Engineer			Liquid Waste		
A.C.E. Design			Traffic		
A.C.E. Hydrology			Water		
DRAWING NO.			SHEET 3 OF 18		

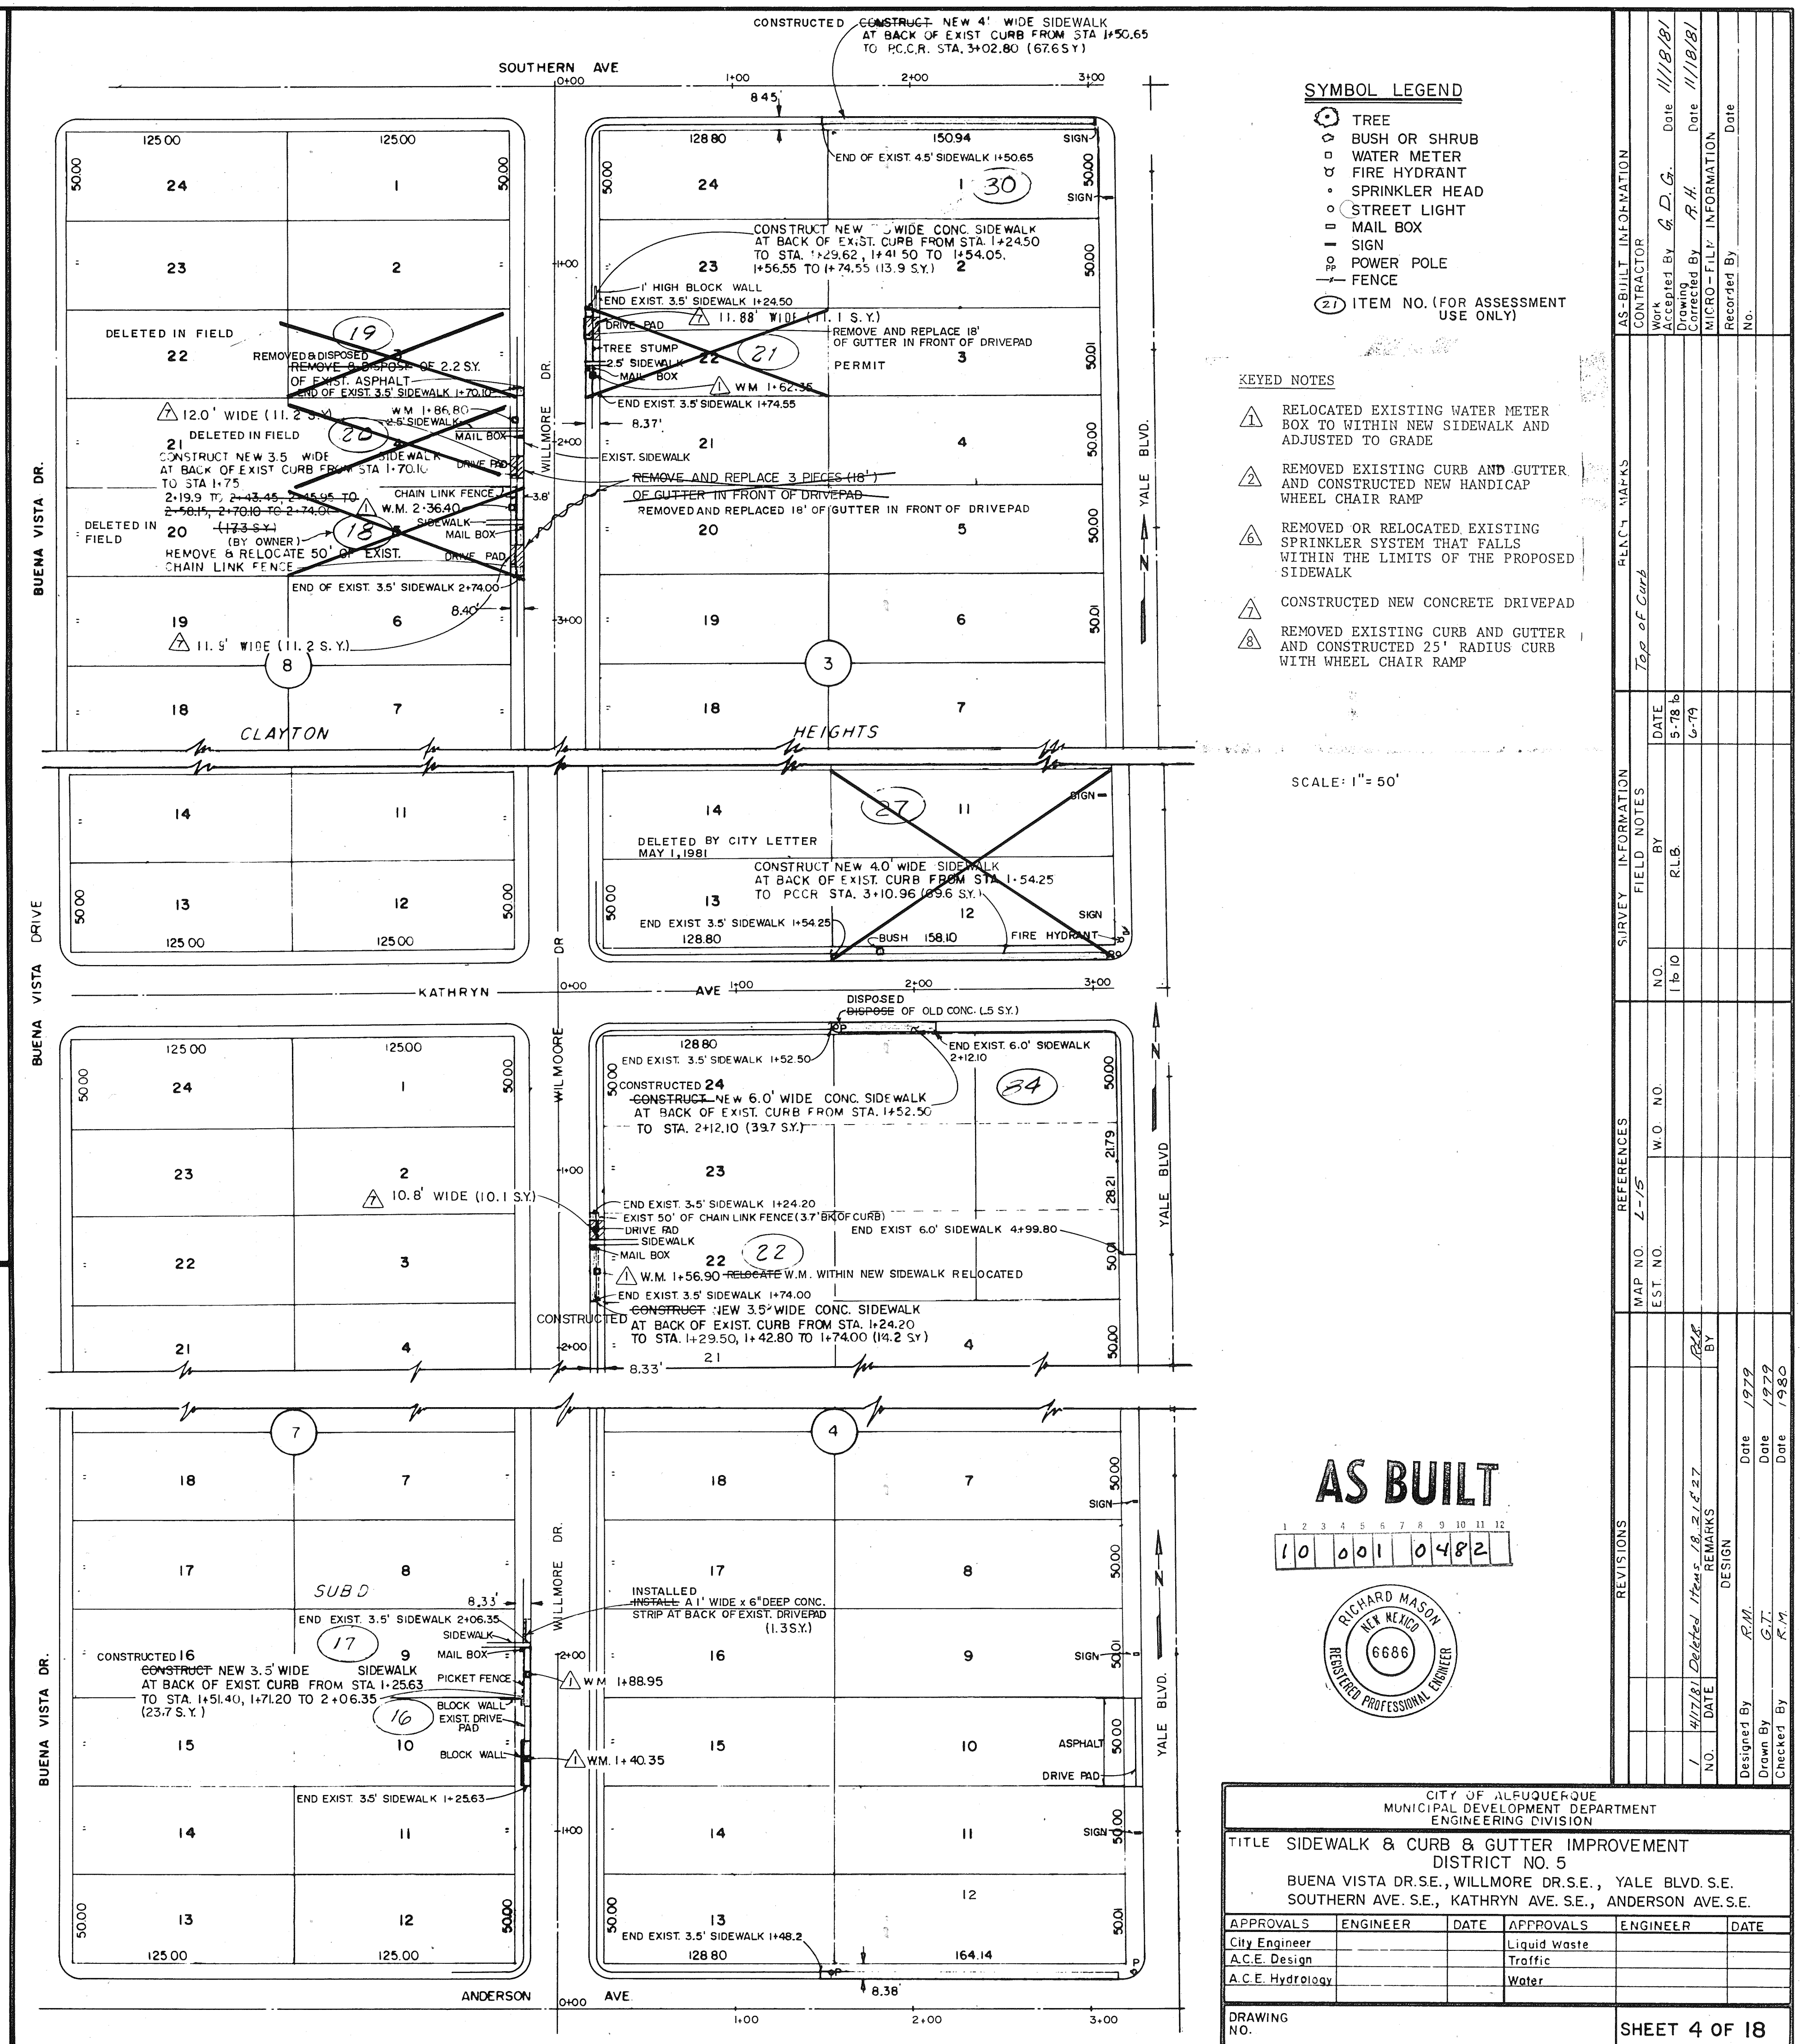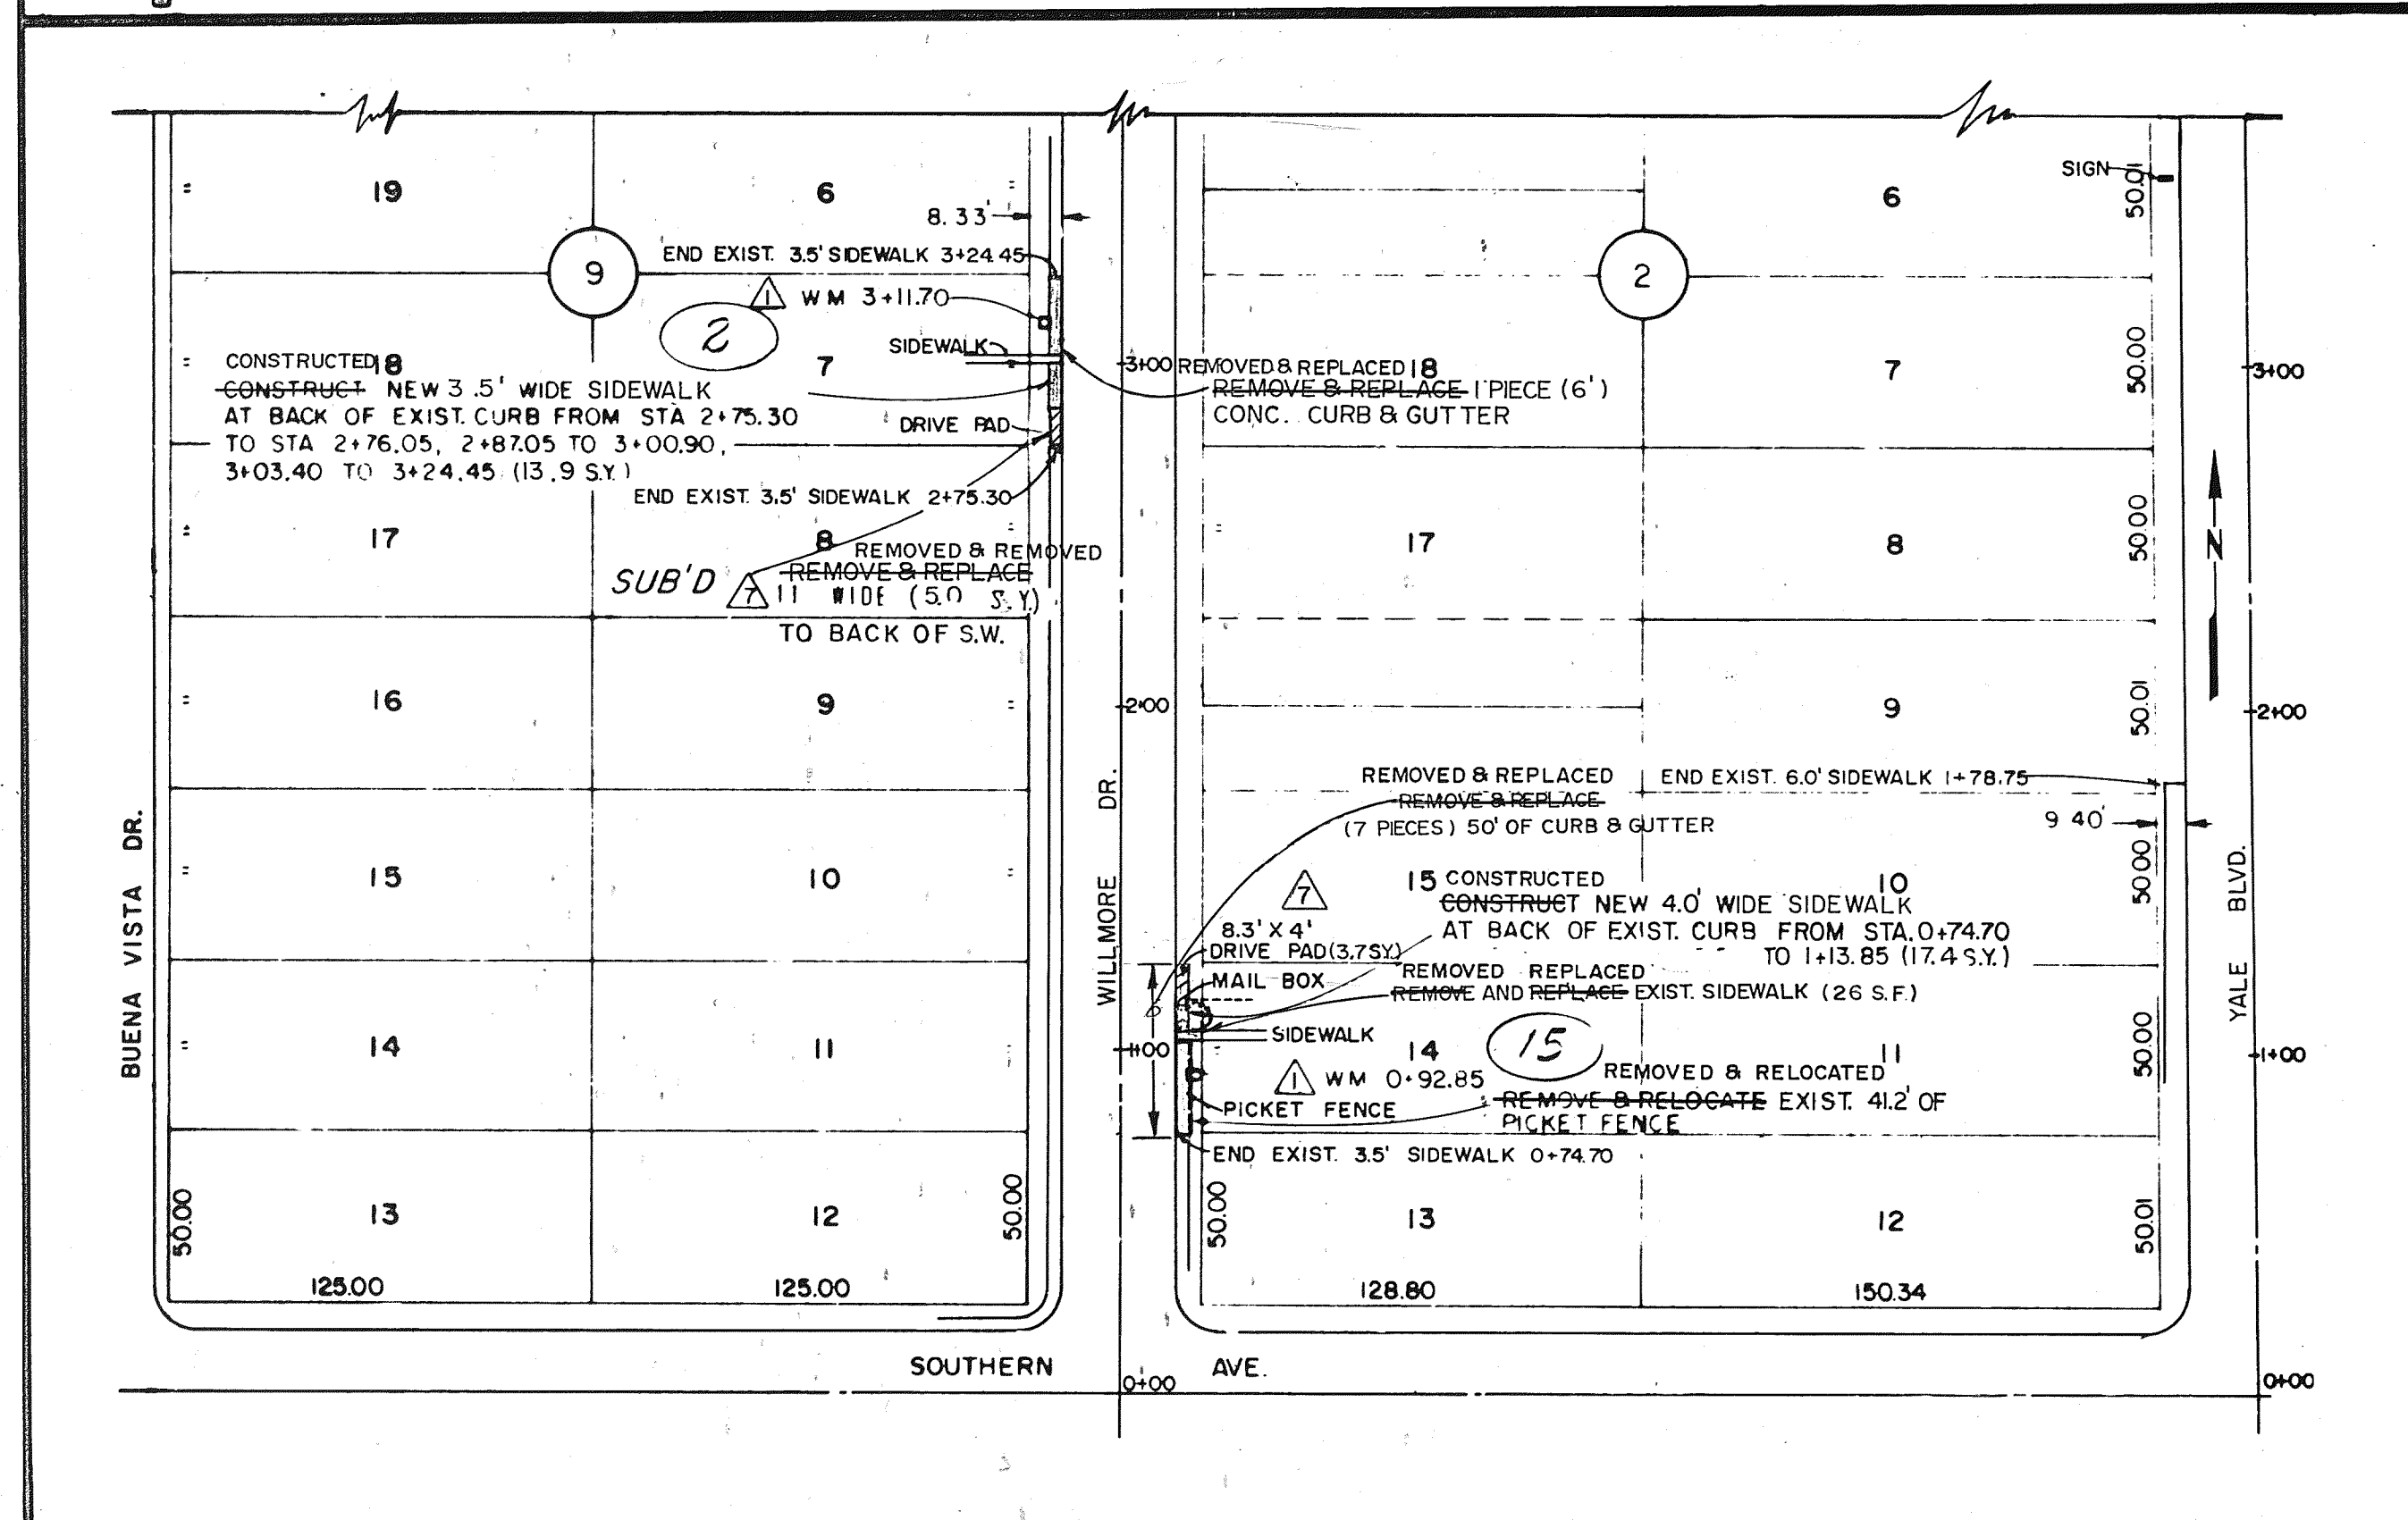

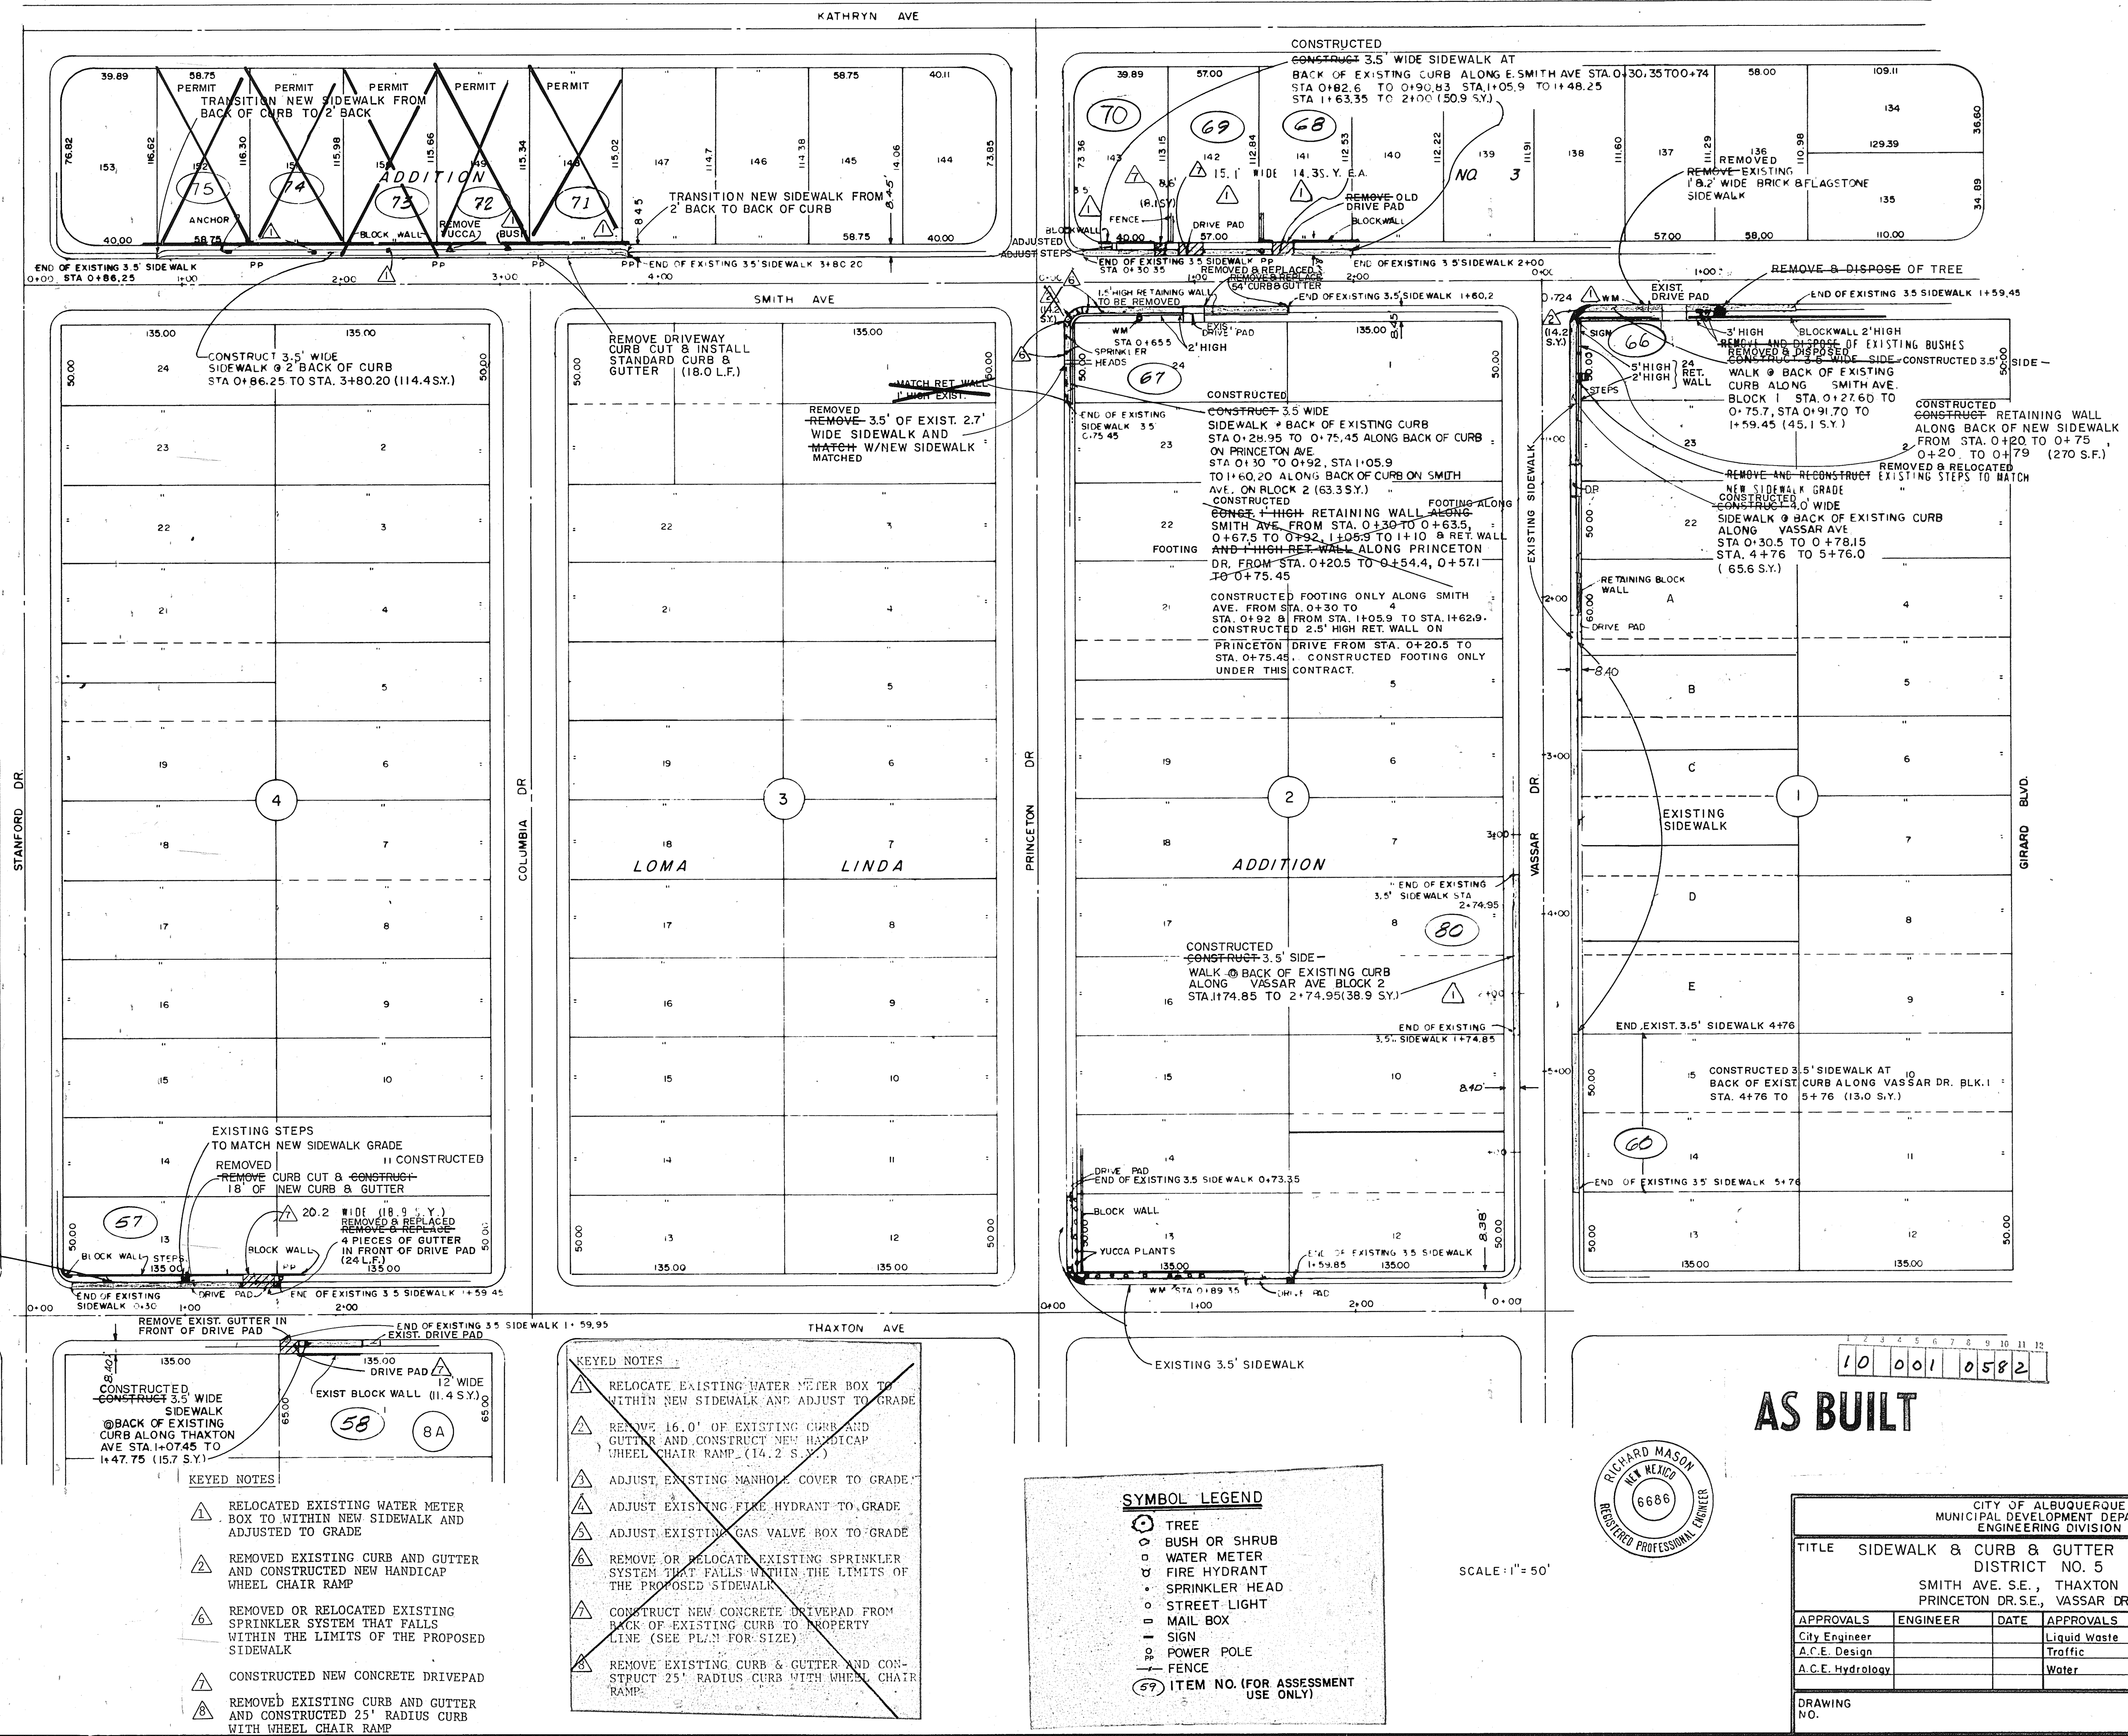[illegible]

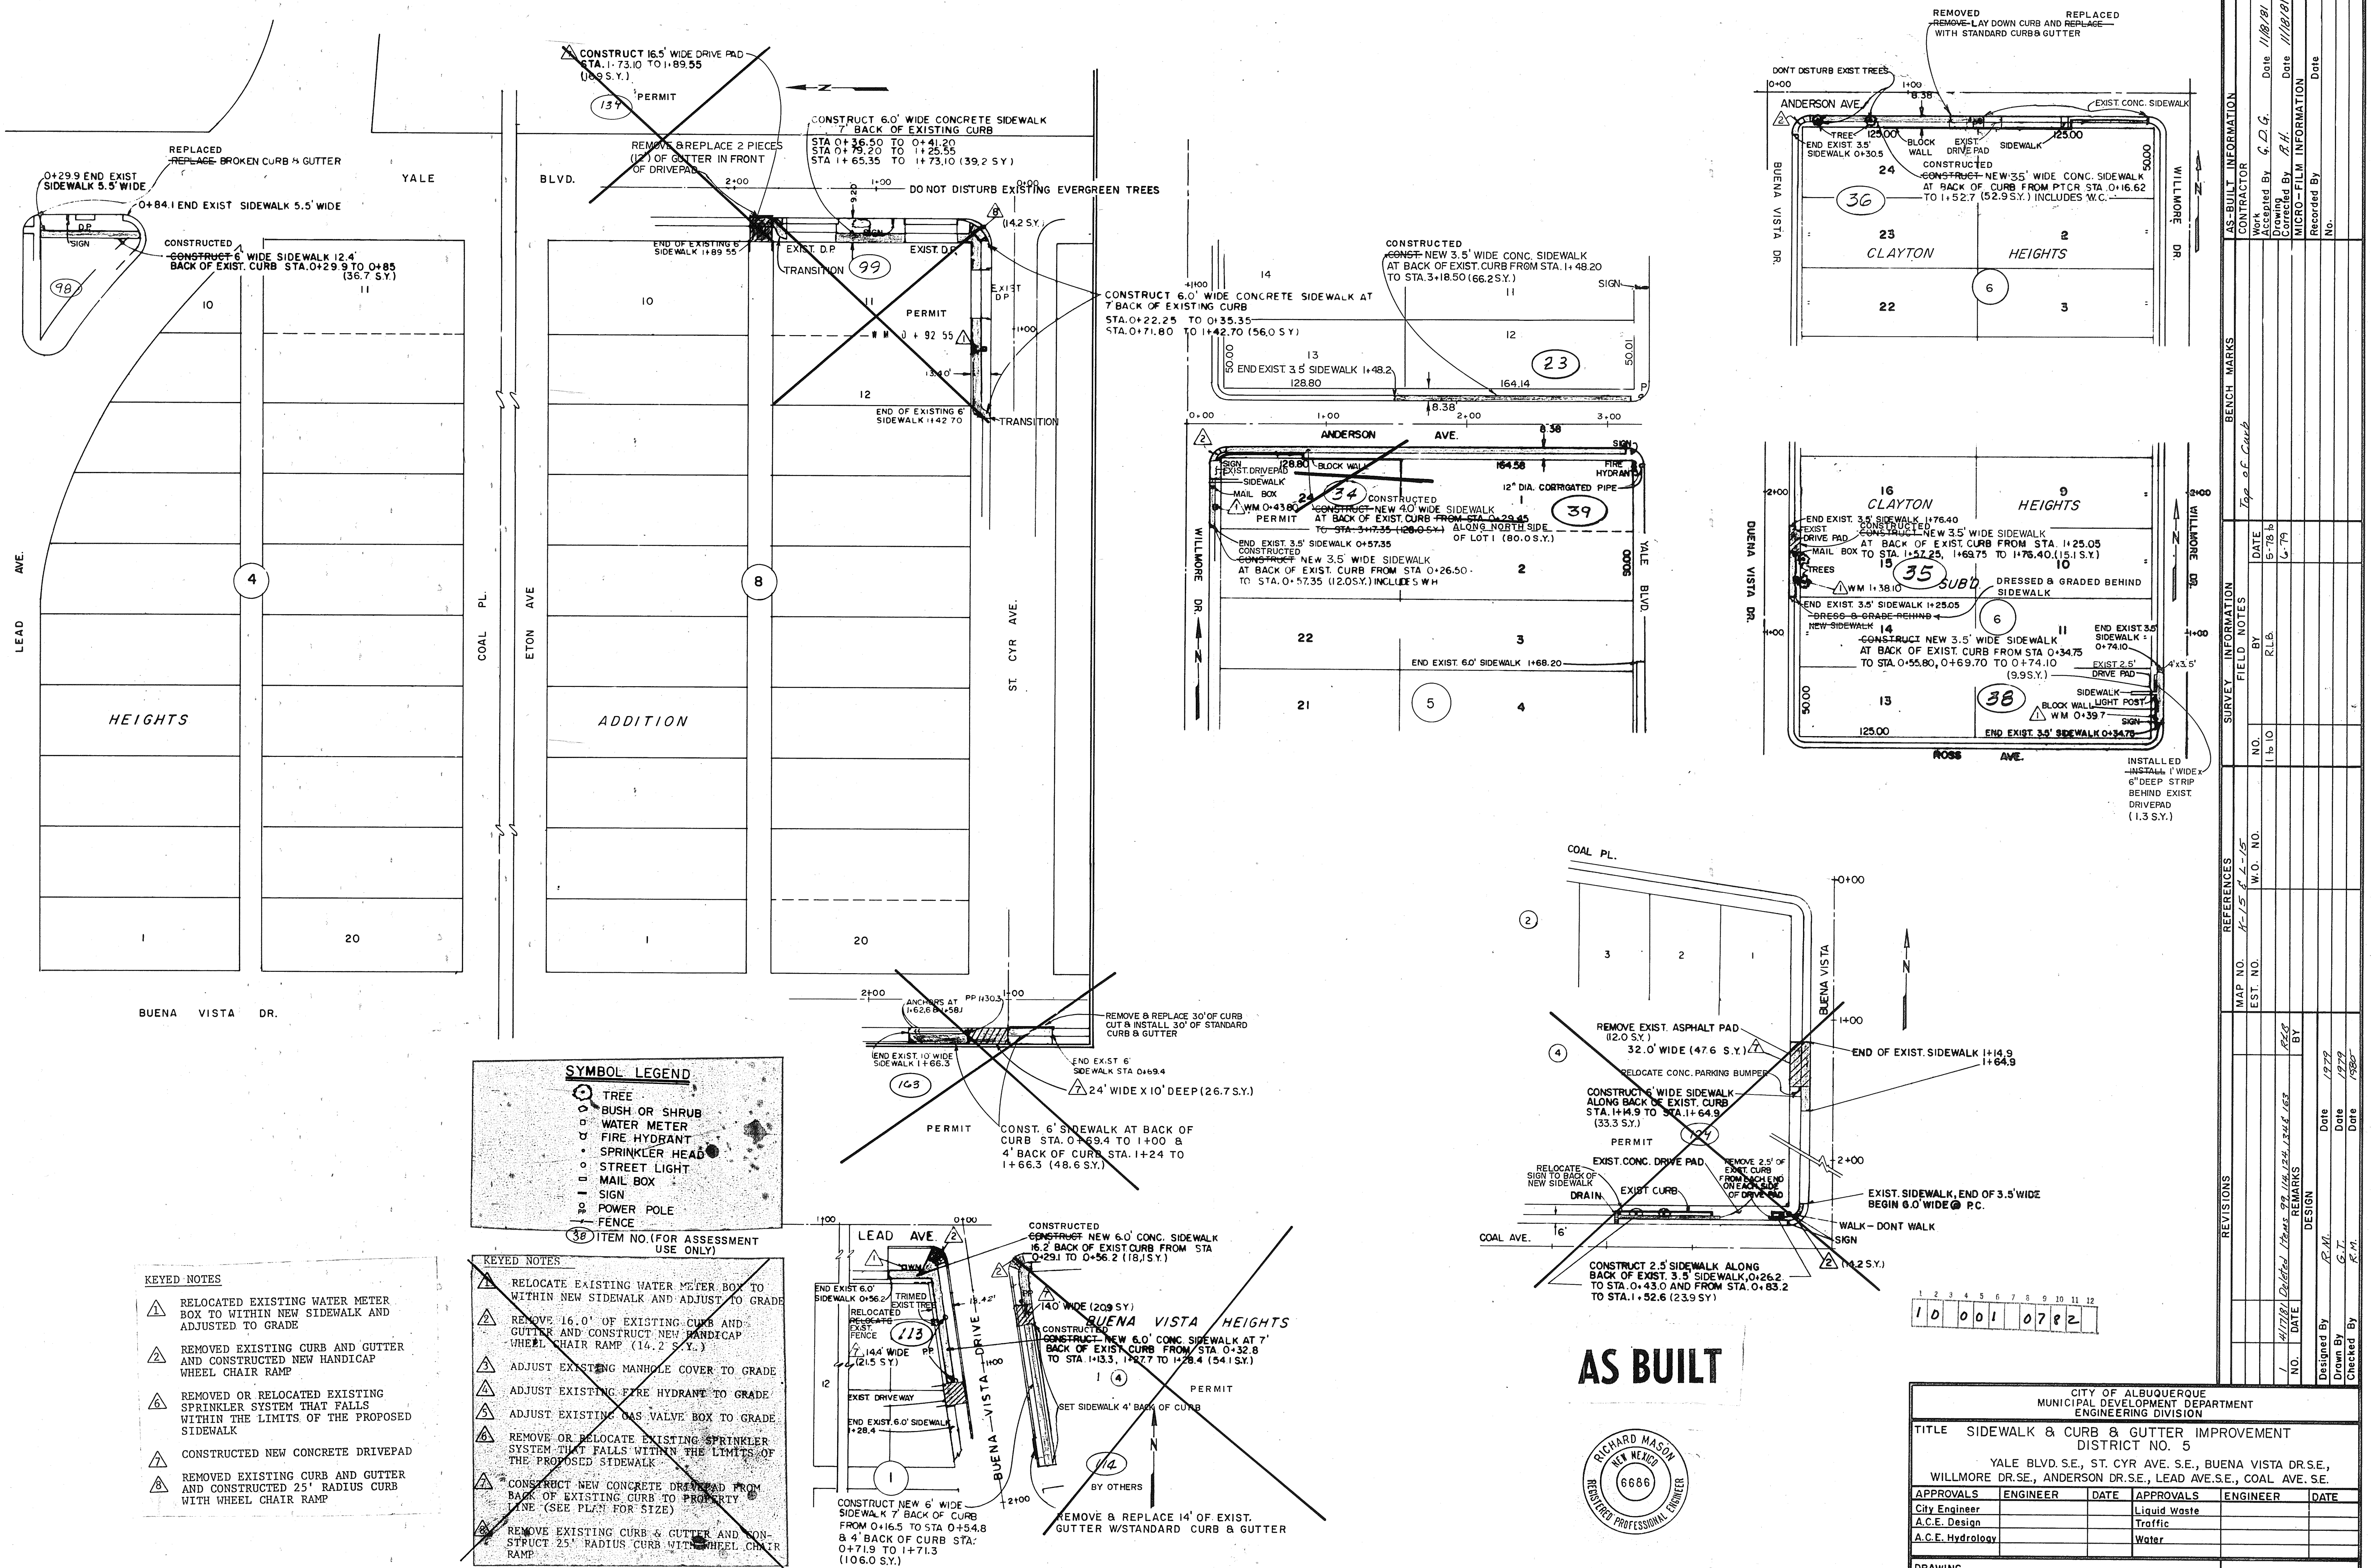

SYMBOL LEGEND

- TREE
- BUSH OR SHRUB
- WATER METER
- FIRE HYDRANT
- SPRINKLER HEAD
- STREET LIGHT
- MAIL BOX
- SIGN
- POWER POLE
- FENCE

38 ITEM NO. (FOR ASSESSMENT USE ONLY)

- KEYED NOTES**
- 1. RELOCATED EXISTING WATER METER BOX TO WITHIN NEW SIDEWALK AND ADJUSTED TO GRADE
 - 2. REMOVED EXISTING CURB AND GUTTER AND CONSTRUCTED NEW HANDICAP WHEEL CHAIR RAMP
 - 3. REMOVED OR RELOCATED EXISTING SPRINKLER SYSTEM THAT FALLS WITHIN THE LIMITS OF THE PROPOSED SIDEWALK
 - 4. CONSTRUCTED NEW CONCRETE DRIVEPAD
 - 5. REMOVED EXISTING CURB AND GUTTER AND CONSTRUCTED 25' RADIUS CURB WITH WHEEL CHAIR RAMP

- KEYED NOTES**
- 1. RELOCATE EXISTING WATER METER BOX TO WITHIN NEW SIDEWALK AND ADJUST TO GRADE
 - 2. REMOVE 16.0' OF EXISTING CURB AND GUTTER AND CONSTRUCT NEW HANDICAP WHEEL CHAIR RAMP (14.2 S.Y.)
 - 3. ADJUST EXISTING MANHOLE COVER TO GRADE
 - 4. ADJUST EXISTING FIRE HYDRANT TO GRADE
 - 5. ADJUST EXISTING GAS VALVE BOX TO GRADE
 - 6. REMOVE OR RELOCATE EXISTING SPRINKLER SYSTEM THAT FALLS WITHIN THE LIMITS OF THE PROPOSED SIDEWALK
 - 7. CONSTRUCT NEW CONCRETE DRIVEPAD FROM BACK OF EXISTING CURB TO PROPERTY LINE (SEE PLAN FOR SIZE)
 - 8. REMOVE EXISTING CURB & GUTTER AND CONSTRUCT 25' RADIUS CURB WITH WHEEL CHAIR RAMP

AS BUILT





10 0 0 1 0 7 8 2

CITY OF ALBUQUERQUE MUNICIPAL DEVELOPMENT DEPARTMENT ENGINEERING DIVISION					
TITLE SIDEWALK & CURB & GUTTER IMPROVEMENT DISTRICT NO. 5					
YALE BLVD. S.E., ST. CYR AVE. S.E., BUENA VISTA DR. S.E., WILLMORE DR. S.E., ANDERSON DR. S.E., COAL AVE. S.E.					
APPROVALS	ENGINEER	DATE	APPROVALS	ENGINEER	DATE
City Engineer			Liquid Waste		
A.C.E. Design			Traffic		
A.C.E. Hydrology			Water		



REVISIONS				REFERENCES			SURVEY INFORMATION			BENCH MARKS		AS-BUILT INFORMATION	
		MAP NO.	W.O. NO.	FIELD NOTES									
		EST. NO.		NO.	BY	DATE							
1	4/17/81 Deleted 1149, 150, 152 & 160	PLR		1 to 10	RLB	5-78 to 6-79							
		REMARKS		BY									
Designed By		Date		1979									
Drawn By		Date		1979									
Checked By		Date		1980									
Work Accepted By G.D.G. Date 11/18/81													
Corrected By R.H. Date 11/18/81													
MICRO-FILM INFORMATION													
Recorded By												Date	
No.													

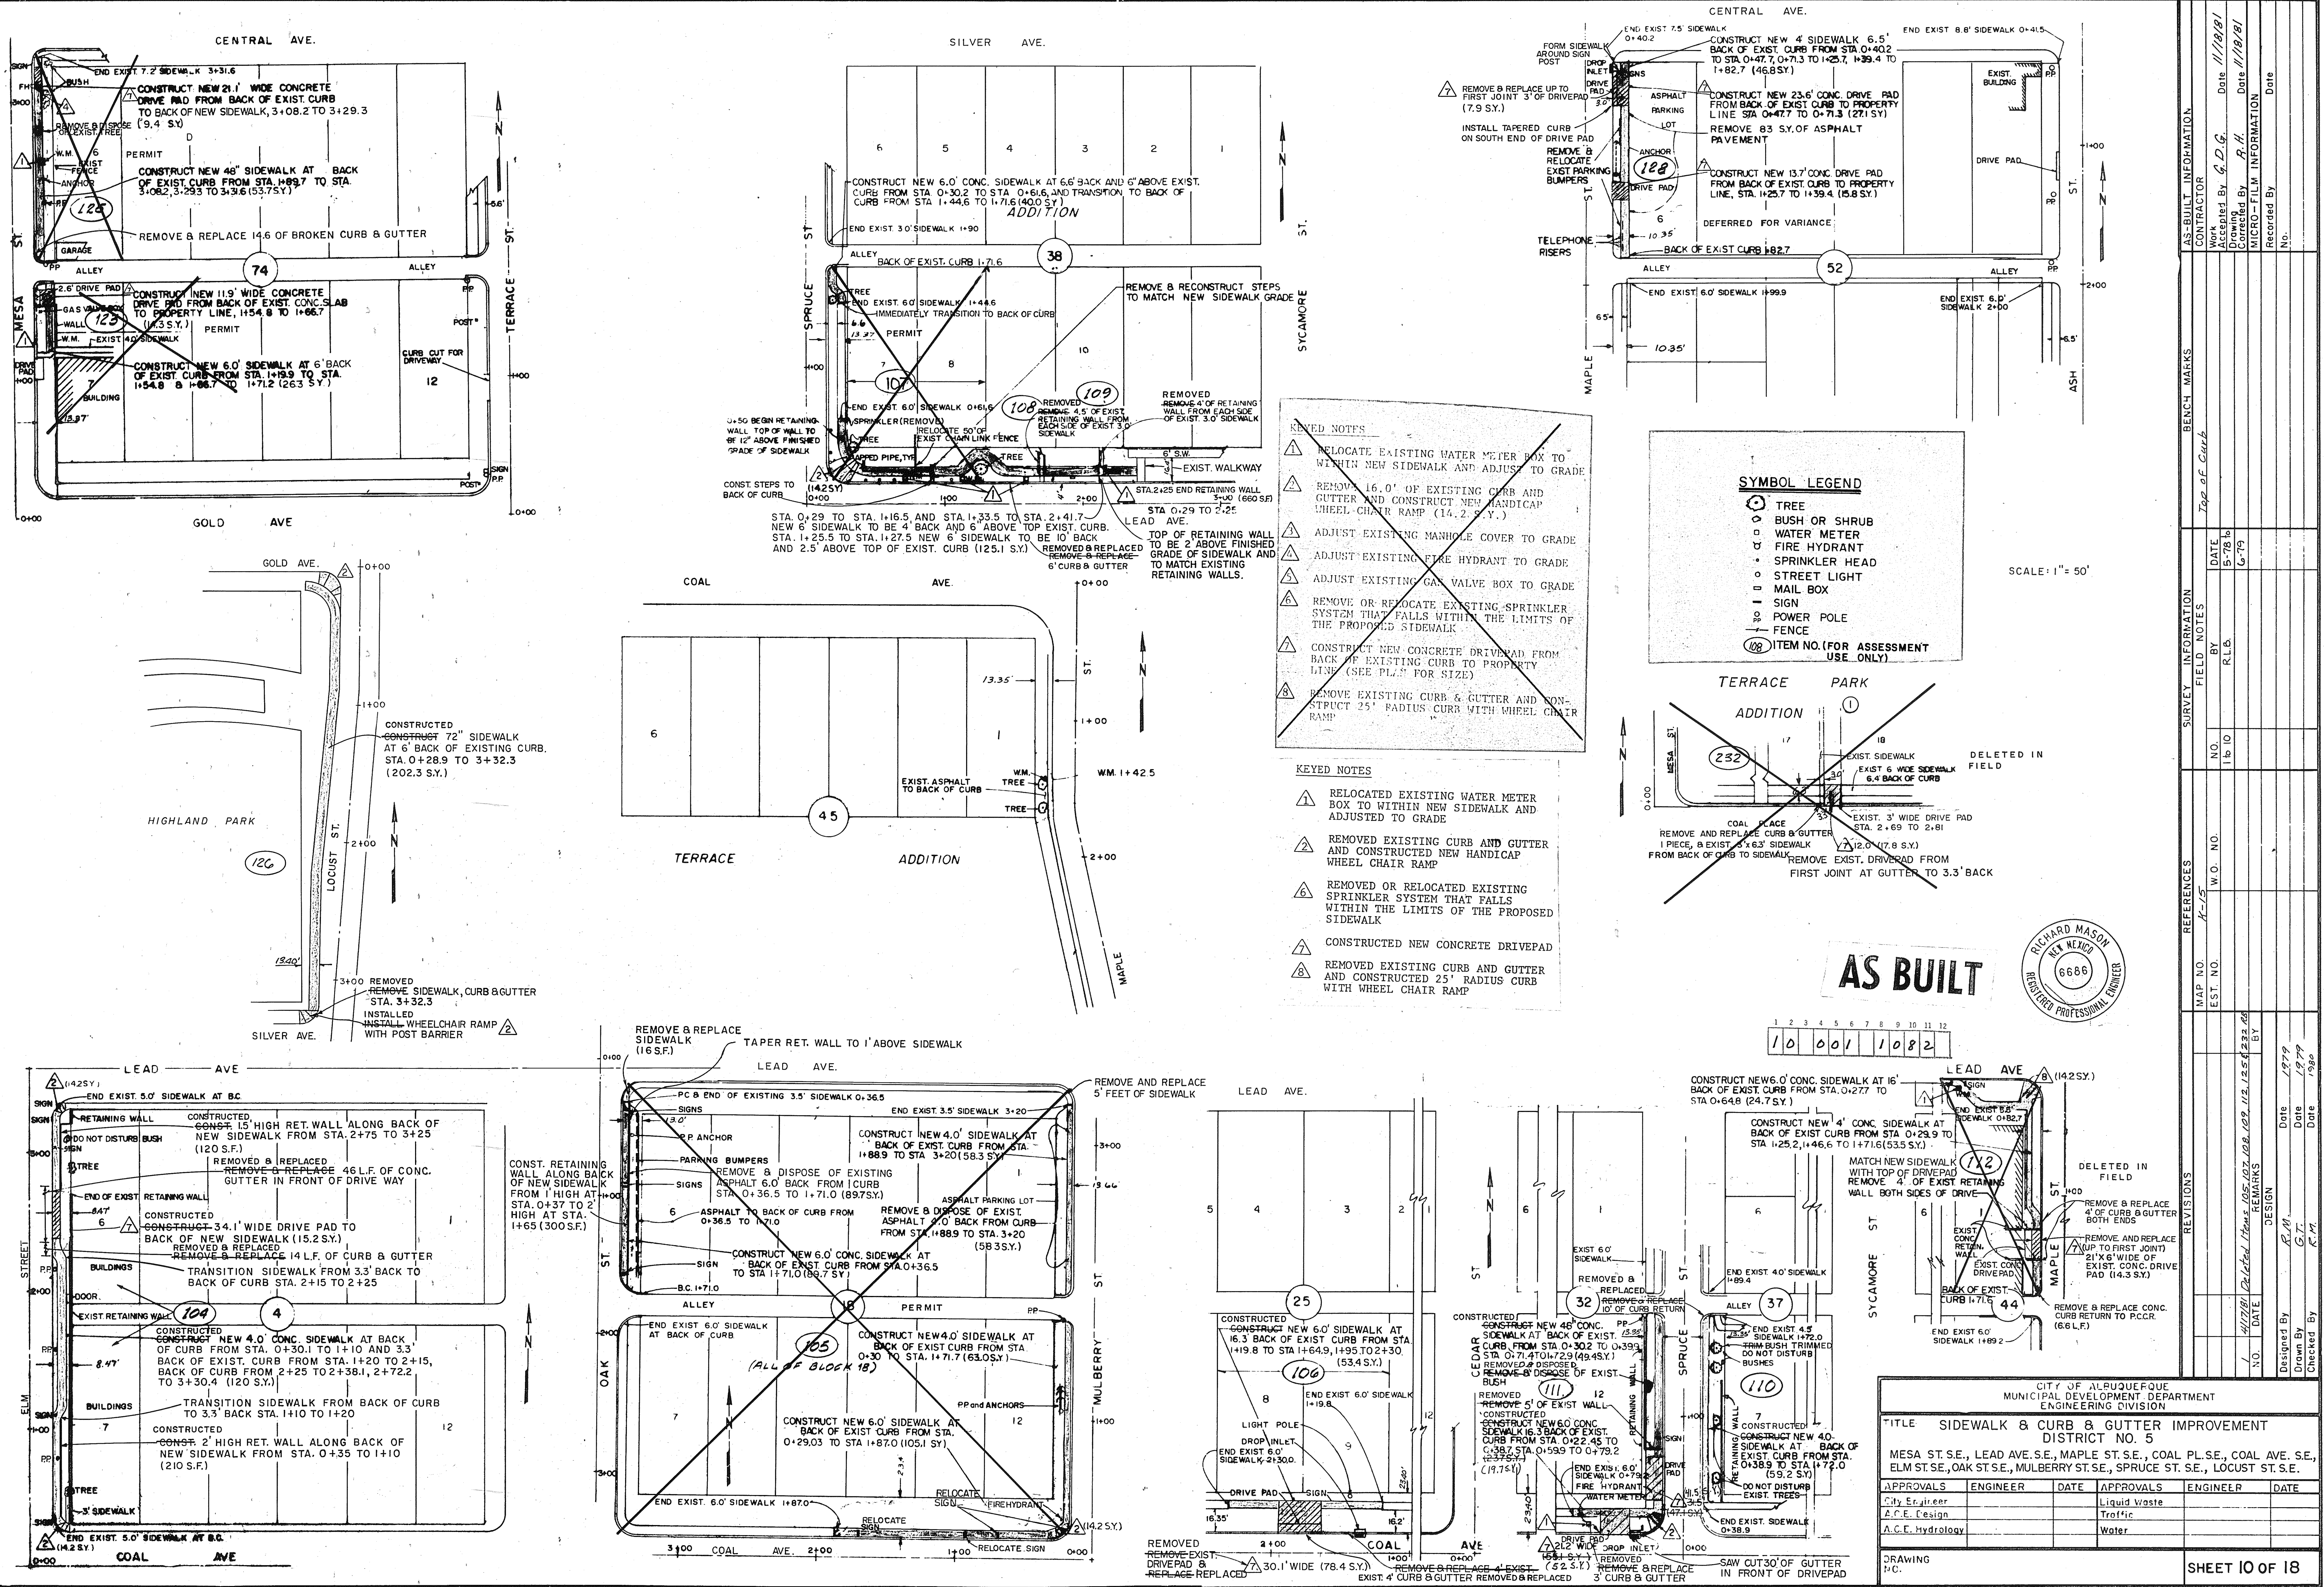

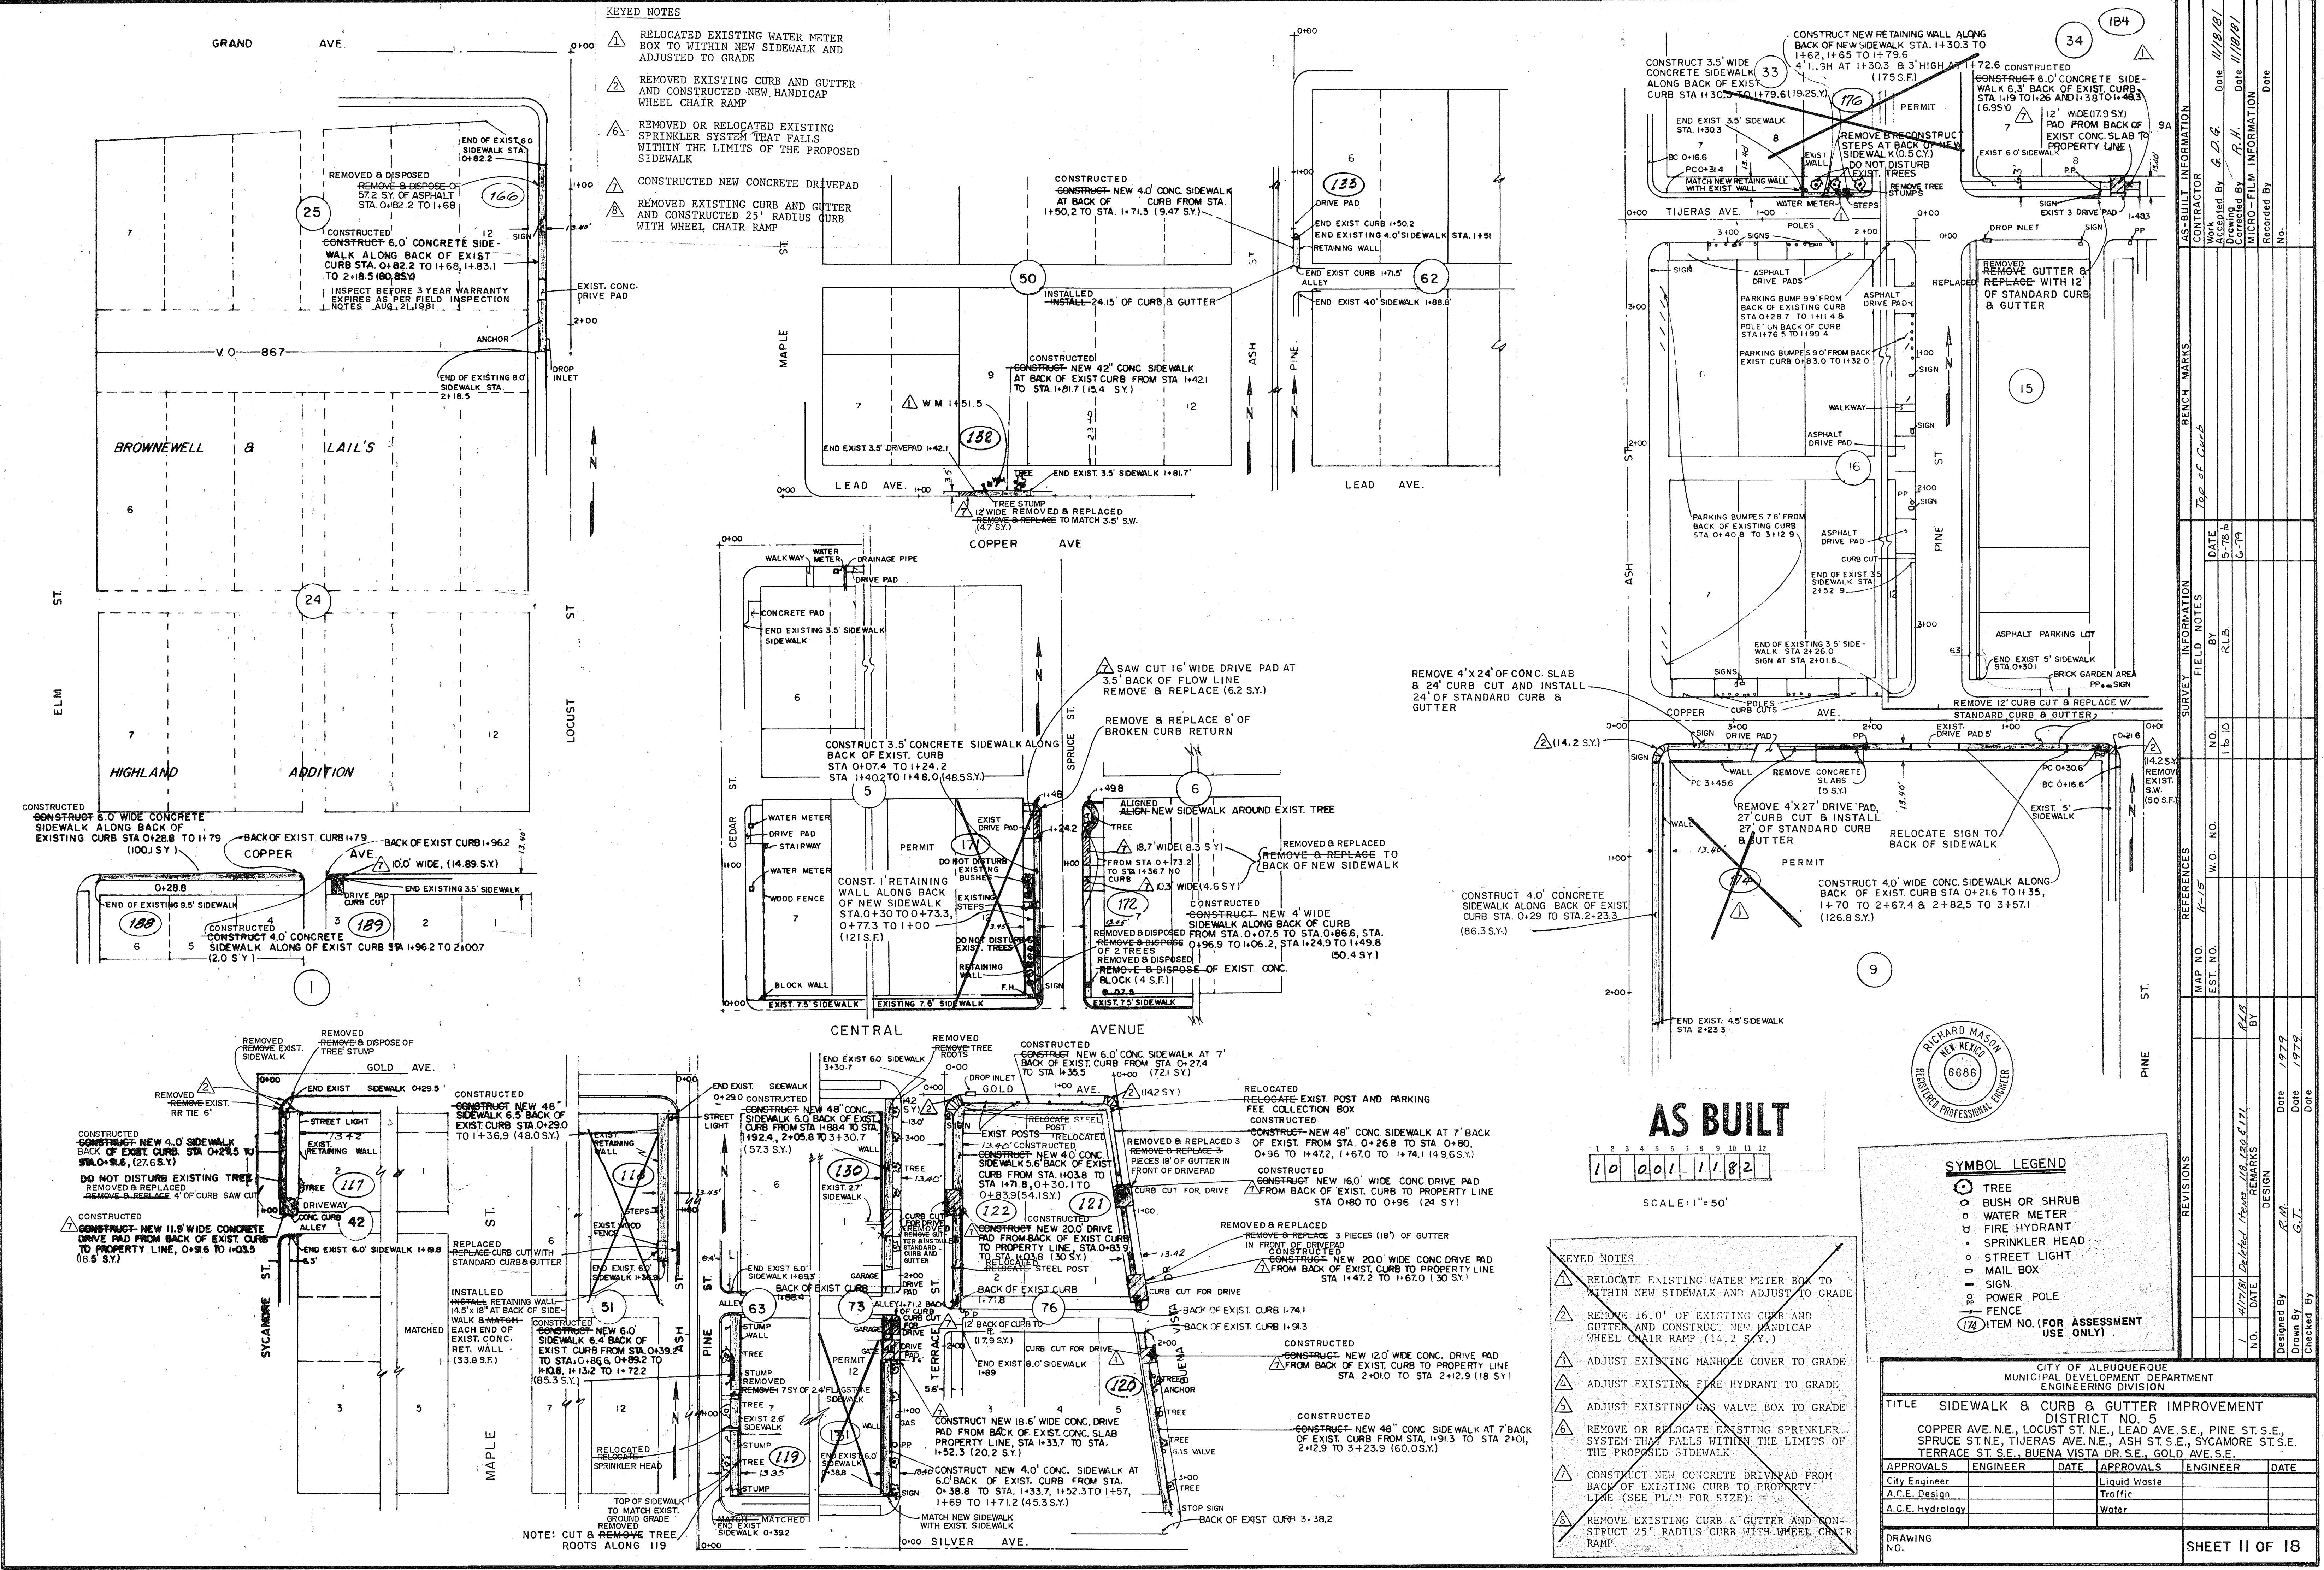

KEYED NOTES

- RELOCATE EXISTING WATER METER BOX TO WITHIN NEW SIDEWALK AND ADJUST TO GRADE
- REMOVE EXISTING CURB AND GUTTER AND CONSTRUCT NEW HANDICAP WHEEL CHAIR RAMP (14.2 S.Y.)
- ADJUST EXISTING MANHOLE COVER TO GRADE
- ADJUST EXISTING FIRE HYDRANT TO GRADE
- ADJUST EXISTING GAS VALVE BOX TO GRADE
- REMOVE OR RELOCATE EXISTING SPRINKLER SYSTEM THAT FALLS WITHIN THE LIMITS OF THE PROPOSED SIDEWALK
- CONSTRUCT NEW CONCRETE DRIVEPAD FROM BACK OF EXISTING CURB TO PROPERTY LINE (SEE PLAN FOR SIZE)
- REMOVE EXISTING CURB & GUTTER AND CONSTRUCT 25' RADIUS CURB WITH WHEEL CHAIR RAMP

SYMBOL LEGEND

- TREE
- BUSH OR SHRUB
- WATER METER
- FIRE HYDRANT
- SPRINKLER HEAD
- STREET LIGHT
- MAIL BOX
- SIGN
- POWER POLE
- FENCE
- ITEM NO. (FOR ASSESSMENT USE ONLY)


CITY OF ALBUQUERQUE MUNICIPAL DEVELOPMENT ENGINEERING DIVISION					
TITLE SIDEWALK & CURB & GUTTER IMPROVEMENT DISTRICT NO. 5 COPPER AVE. N.E., LOCUST ST. N.E., LEAD AVE. S.E., PINE ST. S.E., SPRUCE ST. N.E., TIJERAS AVE. N.E., ASH ST. S.E., SYCAMORE ST. S.E., TERRACE ST. S.E., BUENA VISTA DR. S.E., GOLD AVE. S.E.					
APPROVALS	ENGINEER	DATE	APPROVALS	ENGINEER	DATE
City Engineer			Liquid Waste		
A.C.E. Design			Traffic		
A.C.E. Hydrology			Water		
DRAWING NO.					
SHEET 11 OF 18					



AS BUILT

1 2 3 4 5 6 7 8 9 10 11 12
10 001 1182

SCALE: 1"=50'

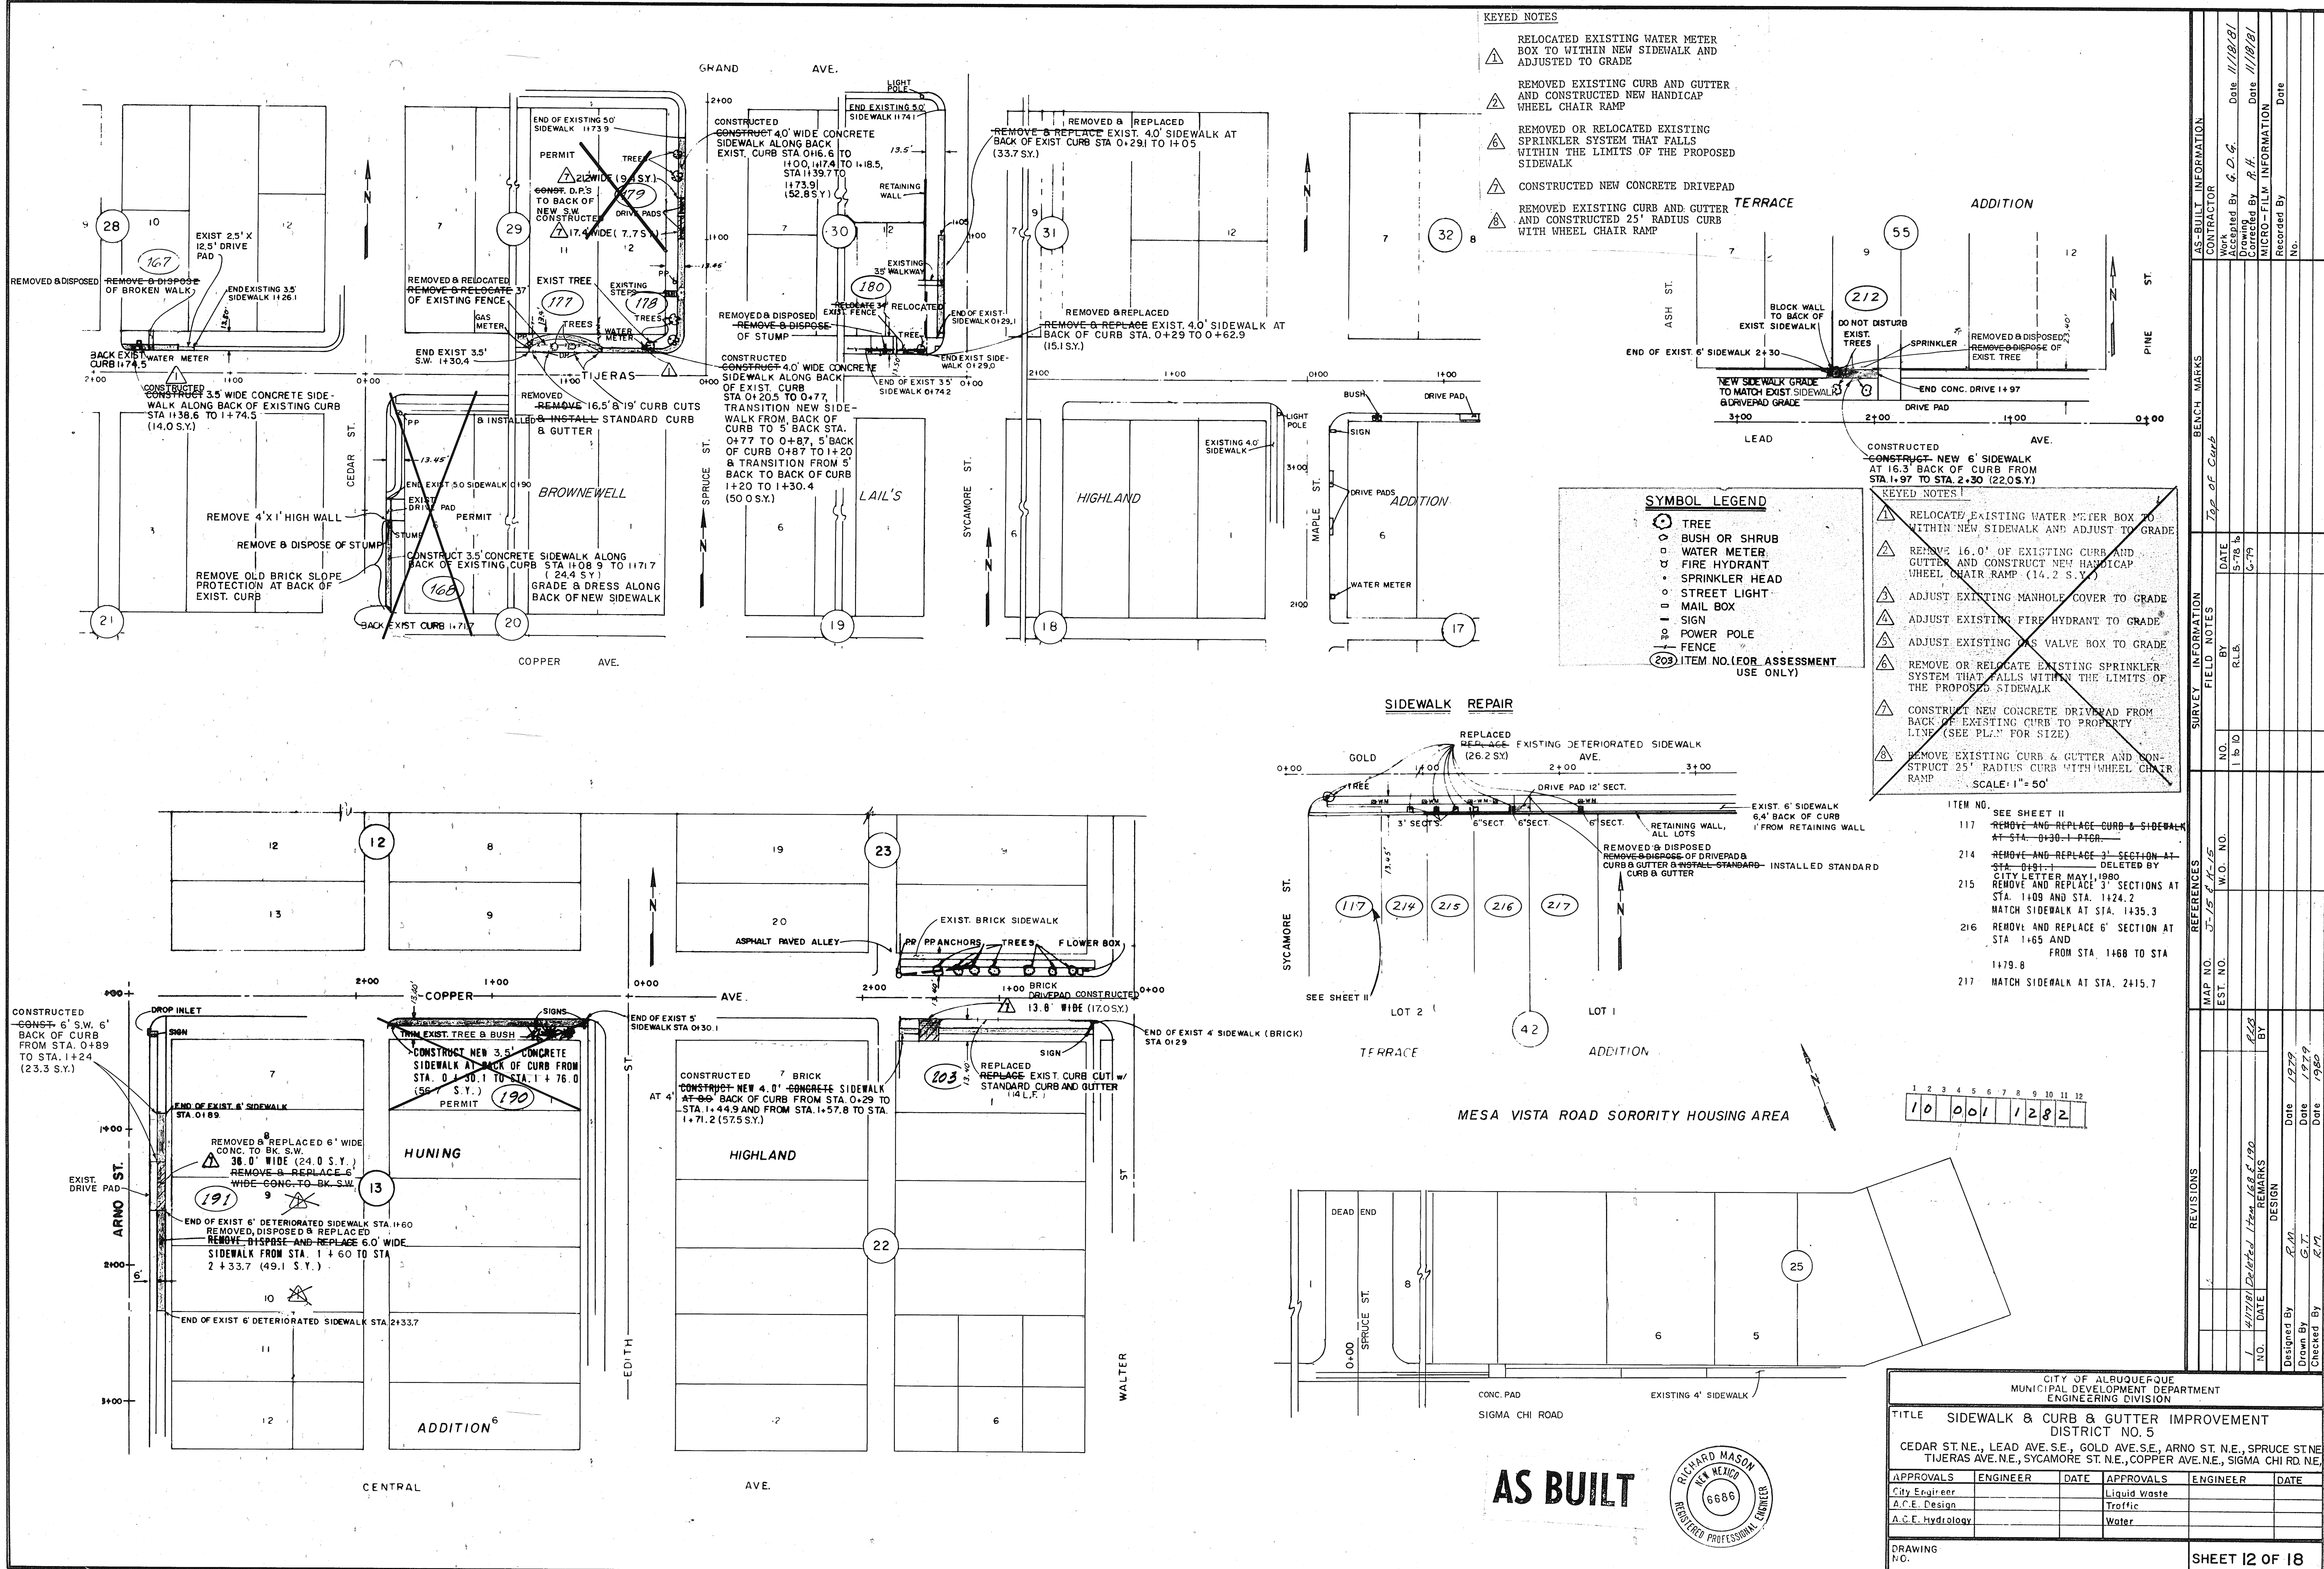


KEYED NOTES

- RELOCATED EXISTING WATER METER BOX TO WITHIN NEW SIDEWALK AND ADJUSTED TO GRADE
- REMOVED EXISTING CURB AND GUTTER AND CONSTRUCTED NEW HANDICAP WHEEL CHAIR RAMP
- REMOVED OR RELOCATED EXISTING SPRINKLER SYSTEM THAT FALLS WITHIN THE LIMITS OF THE PROPOSED SIDEWALK
- CONSTRUCTED NEW CONCRETE DRIVEPAD
- REMOVED EXISTING CURB AND GUTTER AND CONSTRUCTED 25' RADIUS CURB WITH WHEEL CHAIR RAMP


SYMBOL LEGEND

- TREE
- BUSH OR SHRUB
- WATER METER
- FIRE HYDRANT
- SPRINKLER HEAD
- STREET LIGHT
- MAIL BOX
- SIGN
- POWER POLE
- FENCE
- ITEM NO. (FOR ASSESSMENT USE ONLY)

SIDWALK REPAIR

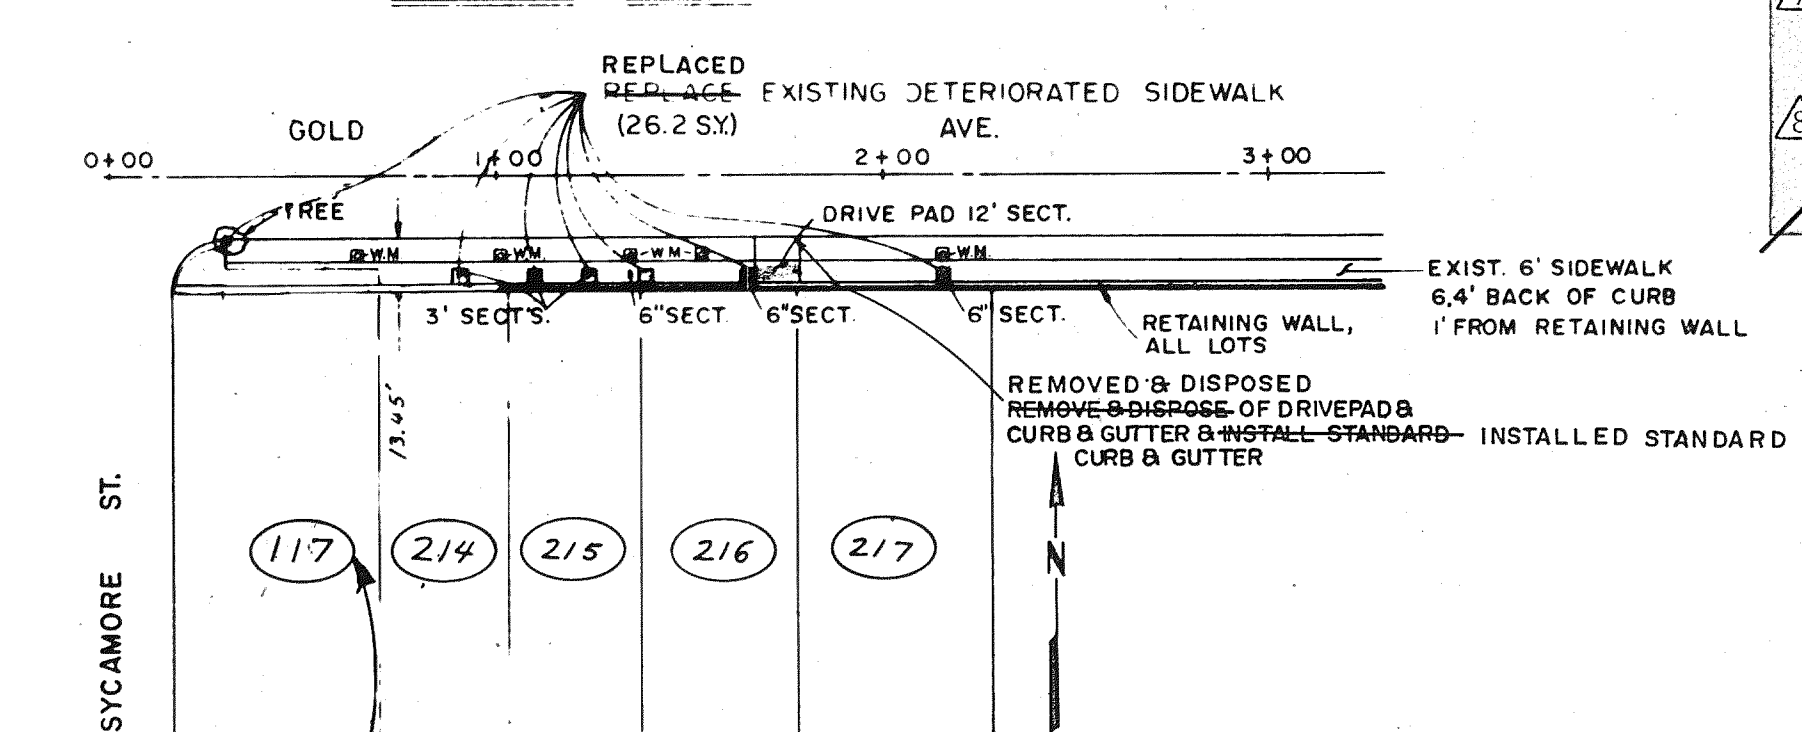

MESA VISTA ROAD SORORITY HOUSING AREA

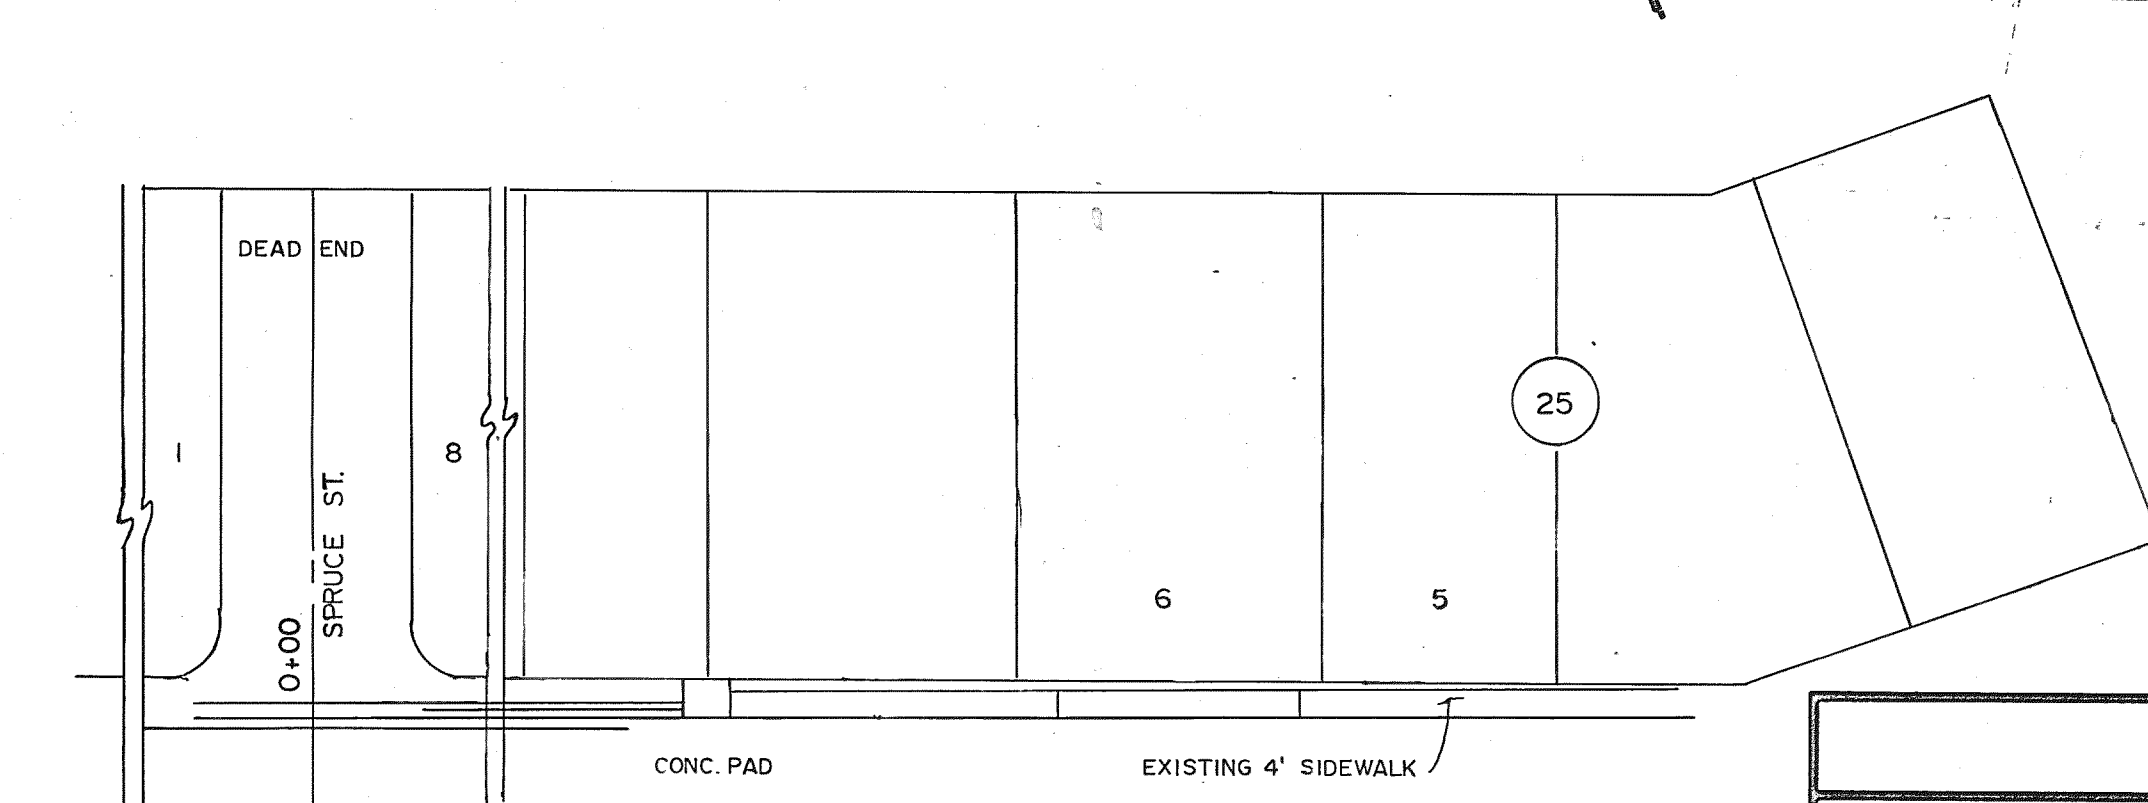


1	2	3	4	5	6	7	8	9	10	11	12
10	0	0	1	1	2	8	2				

AS BUILT



CITY OF ALBUQUERQUE MUNICIPAL DEVELOPMENT DEPARTMENT ENGINEERING DIVISION					
TITLE SIDEWALK & CURB & GUTTER IMPROVEMENT DISTRICT NO. 5 CEDAR ST. NE, LEAD AVE. SE, GOLD AVE. SE, ARNO ST. NE, SPRUCE ST. NE, TIJERAS AVE. NE, SYCAMORE ST. NE, COPPER AVE. NE, SIGMA CHI RD. NE,					
APPROVALS	ENGINEER	DATE	APPROVALS	ENGINEER	DATE
City Engineer			Liquid Waste		
A.C.E. Design			Traffic		
A.C.E. Hydrology			Water		
DRAWING NO.			SHEET 12 OF 18		

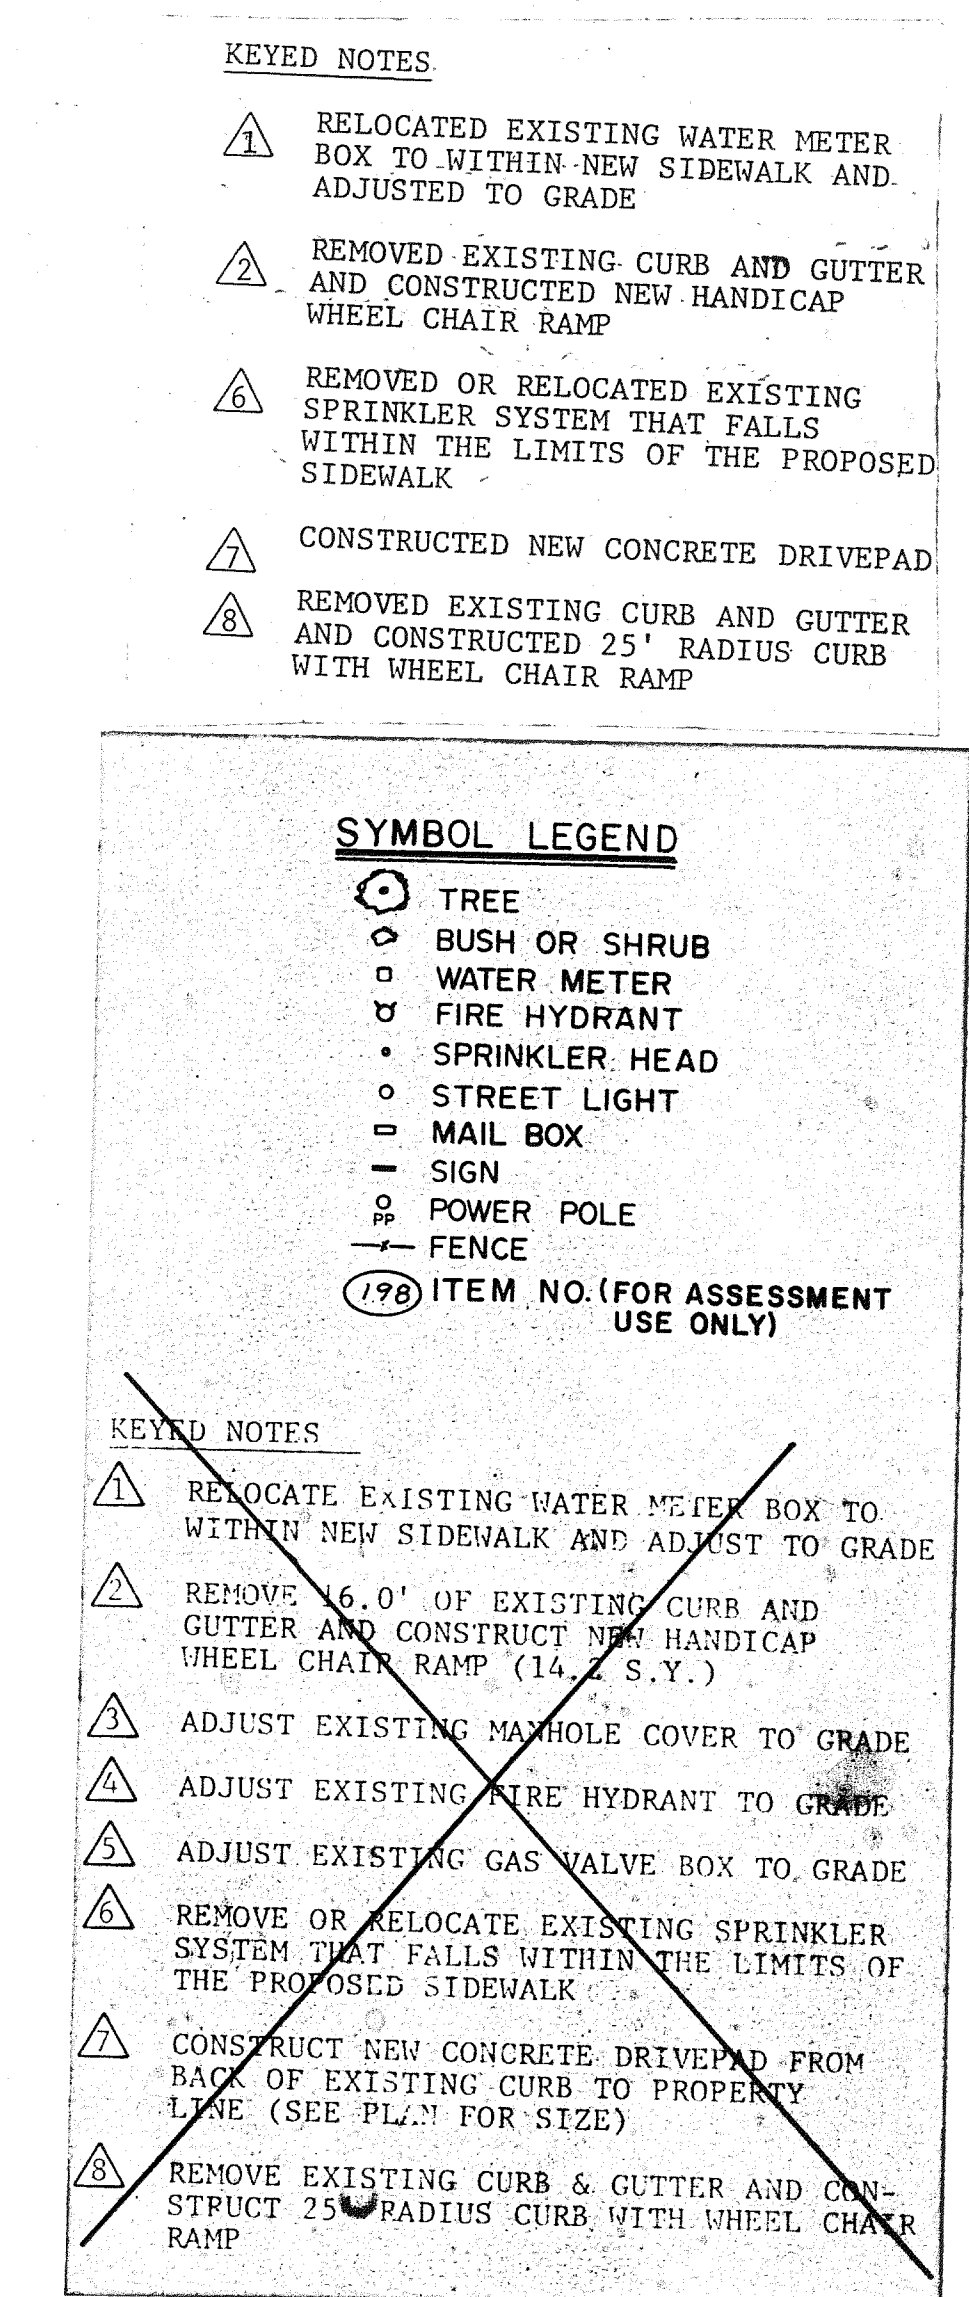[illegible]

SYMBOL LEGEND


- TREE
- BUSH OR SHRUB
- WATER METER
- FIRE HYDRANT
- SPRINKLER HEAD
- STREET LIGHT
- MAIL BOX
- SIGN
- POWER POLE
- FENCE

KEYED NOTES

- RELOCATE EXISTING WATER METER BOX TO WITHIN NEW SIDEWALK AND ADJUST TO GRADE
- REMOVE 16.0' OF EXISTING CURB AND GUTTER AND CONSTRUCT NEW HANDICAP WHEEL CHAIR RAMP (14.2 S.Y.)
- ADJUST EXISTING MANHOLE COVER TO GRADE
- ADJUST EXISTING FIRE HYDRANT TO GRADE
- ADJUST EXISTING GAS VALVE BOX TO GRADE
- REMOVE OR RELOCATE EXISTING SPRINKLER SYSTEM THAT FALLS WITHIN THE LIMITS OF THE PROPOSED SIDEWALK
- CONSTRUCT NEW CONCRETE DRIVEPAD FROM BACK OF EXISTING CURB TO PROPERTY LINE (SEE PLAN FOR SIZE)
- REMOVE EXISTING CURB & GUTTER AND CONSTRUCT 25' RADIUS CURB WITH WHEEL CHAIR RAMP

SCALE: 1" = 50'

ITEM NO. (FOR ASSESSMENT USE ONLY)

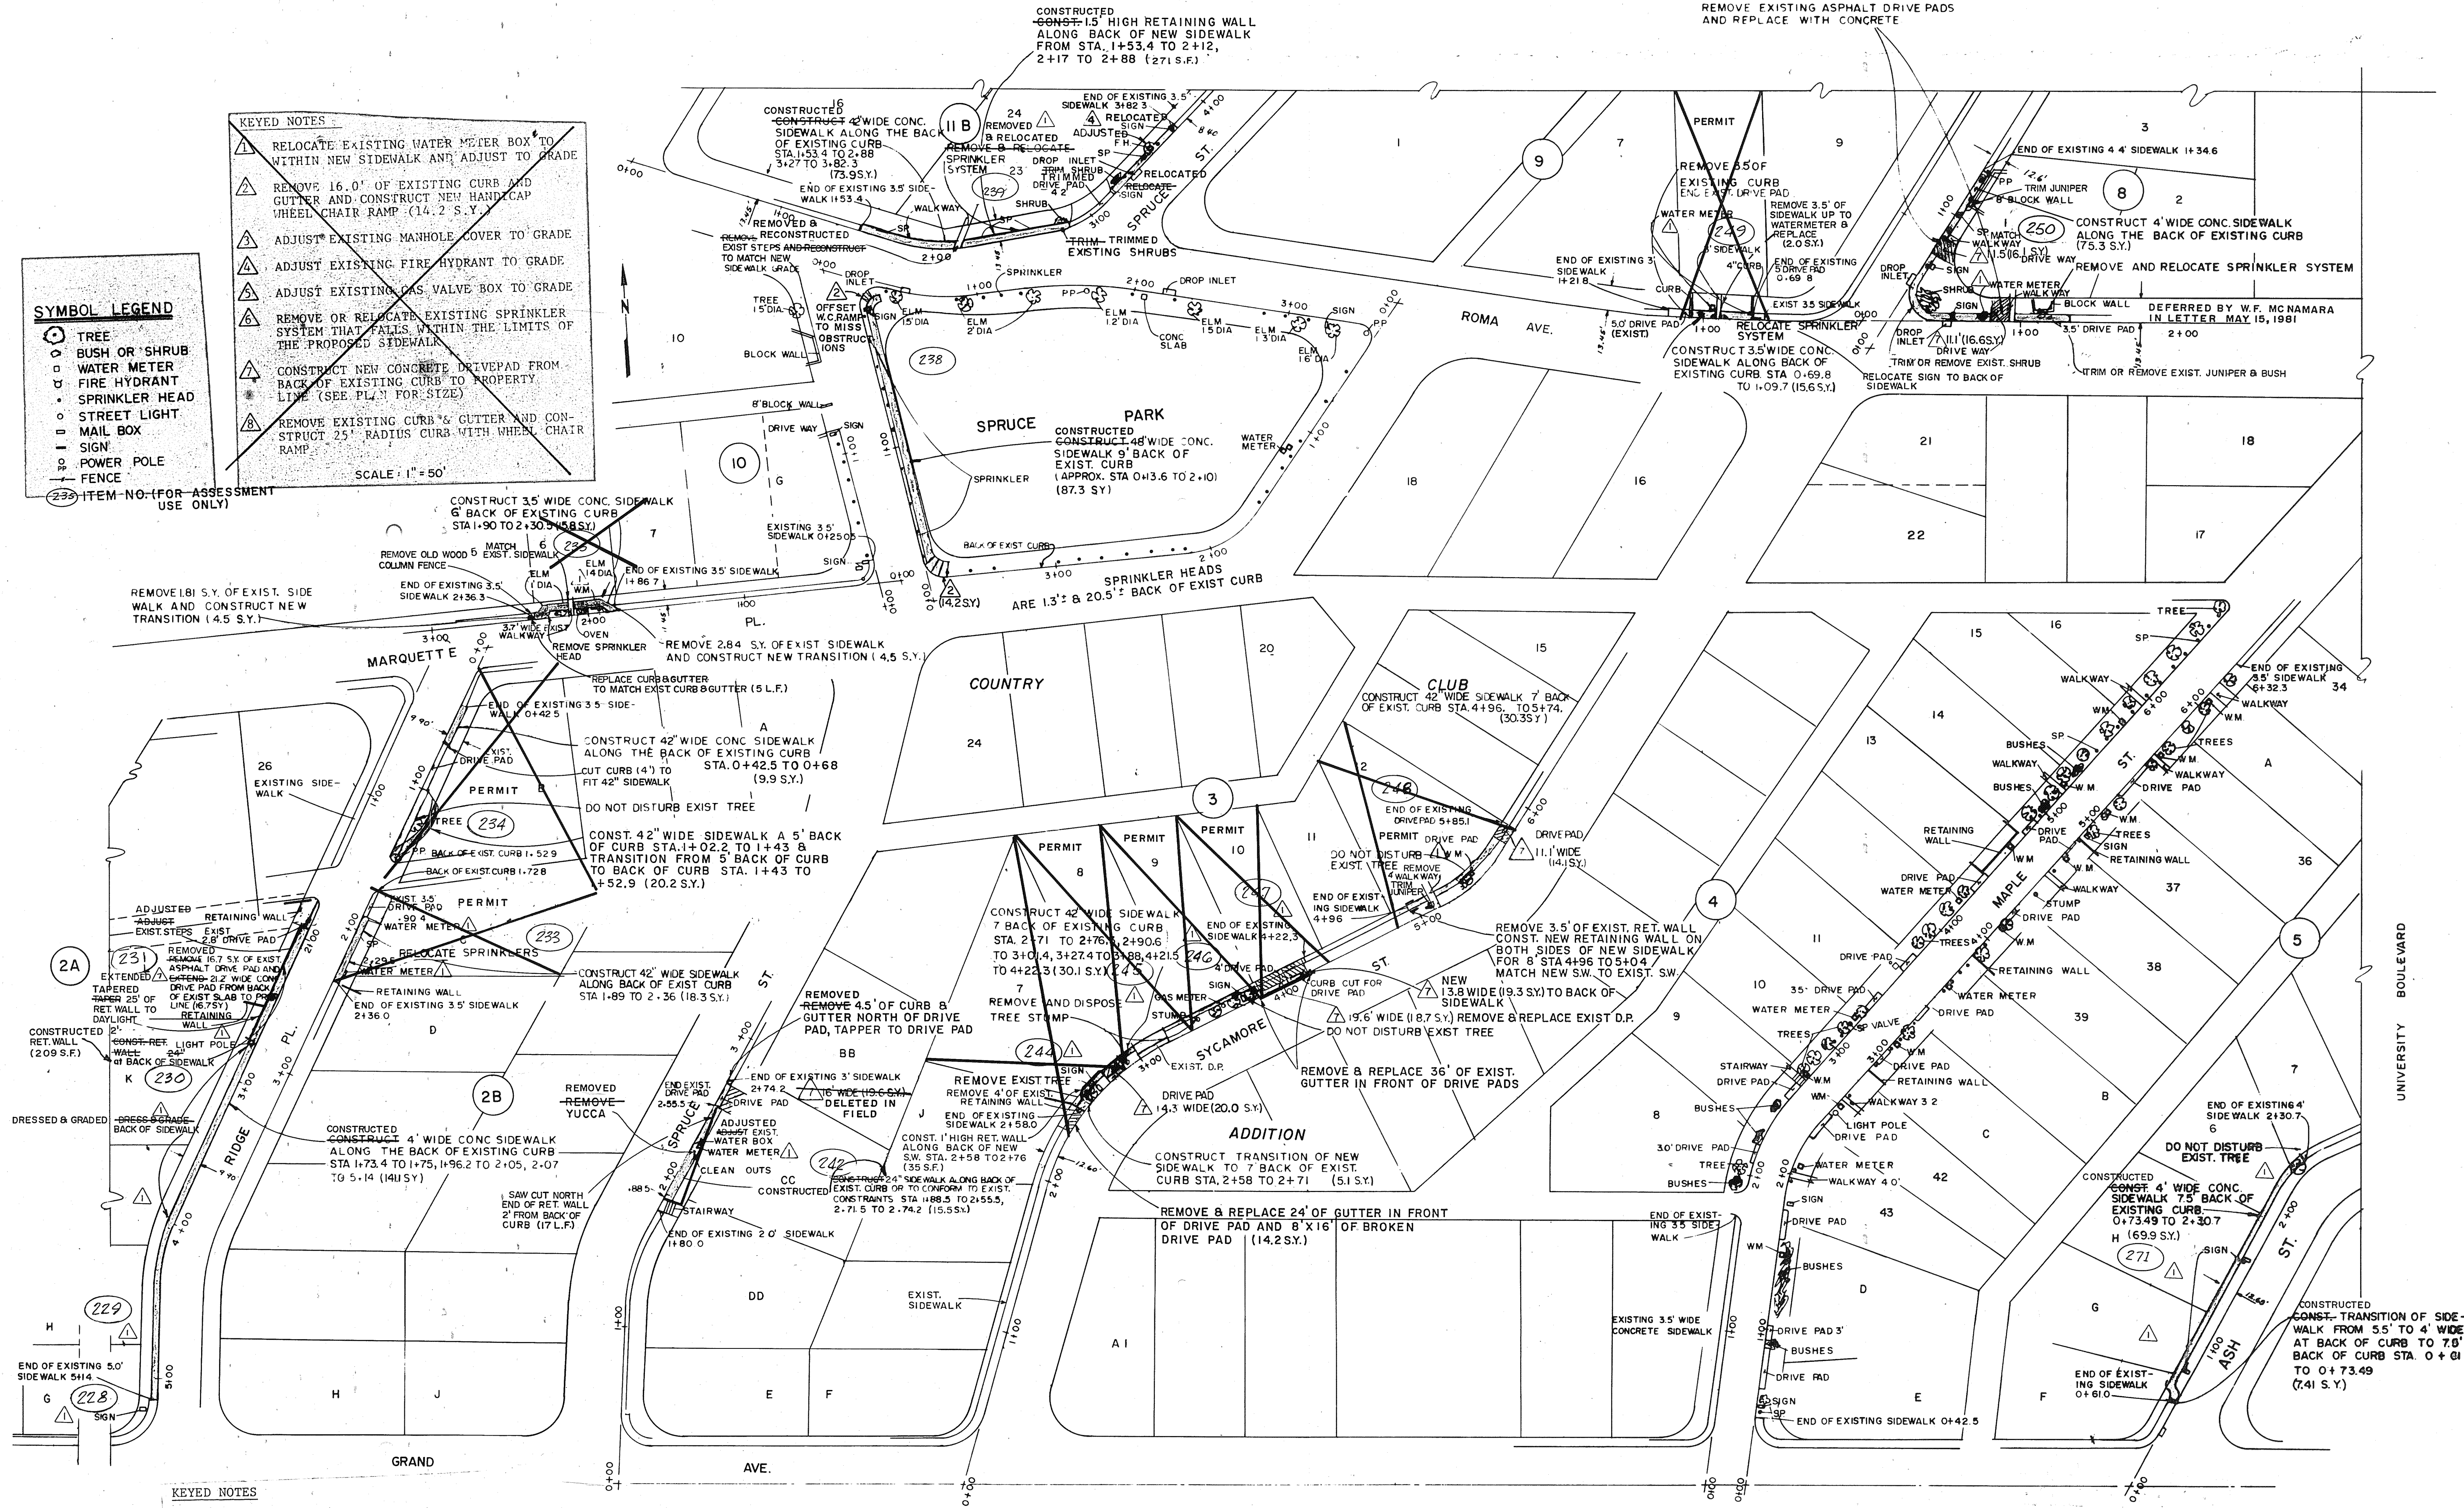


KEYED NOTES

- RELOCATED EXISTING WATER METER BOX TO WITHIN NEW SIDEWALK AND ADJUSTED TO GRADE
- REMOVED EXISTING CURB AND GUTTER AND CONSTRUCTED NEW HANDICAP WHEEL CHAIR RAMP
- REMOVED OR RELOCATED EXISTING SPRINKLER SYSTEM THAT FALLS WITHIN THE LIMITS OF THE PROPOSED SIDEWALK
- CONSTRUCTED NEW CONCRETE DRIVEPAD
- REMOVED EXISTING CURB AND GUTTER AND CONSTRUCTED 25' RADIUS CURB WITH WHEEL CHAIR RAMP


AS BUILT



CITY OF ALBUQUERQUE MUNICIPAL DEVELOPMENT DEPARTMENT ENGINEERING DIVISION					
TITLE SIDEWALK & CURB & GUTTER IMPROVEMENT DISTRICT NO. 5 RIDGE PL. N.E., SPRUCE ST. N.E., SYCAMORE ST. N.E., ROMA AVE. N.E., MARQUETTE PL. N.E., ASH ST. N.E.					
APPROVALS	ENGINEER	DATE	APPROVALS	ENGINEER	DATE
City Engineer			Liquid Waste		
A.C.E. Design			Traffic		
A.C.E. Hydrology			Water		
DRAWING NO.			SHEET 14 OF 18		

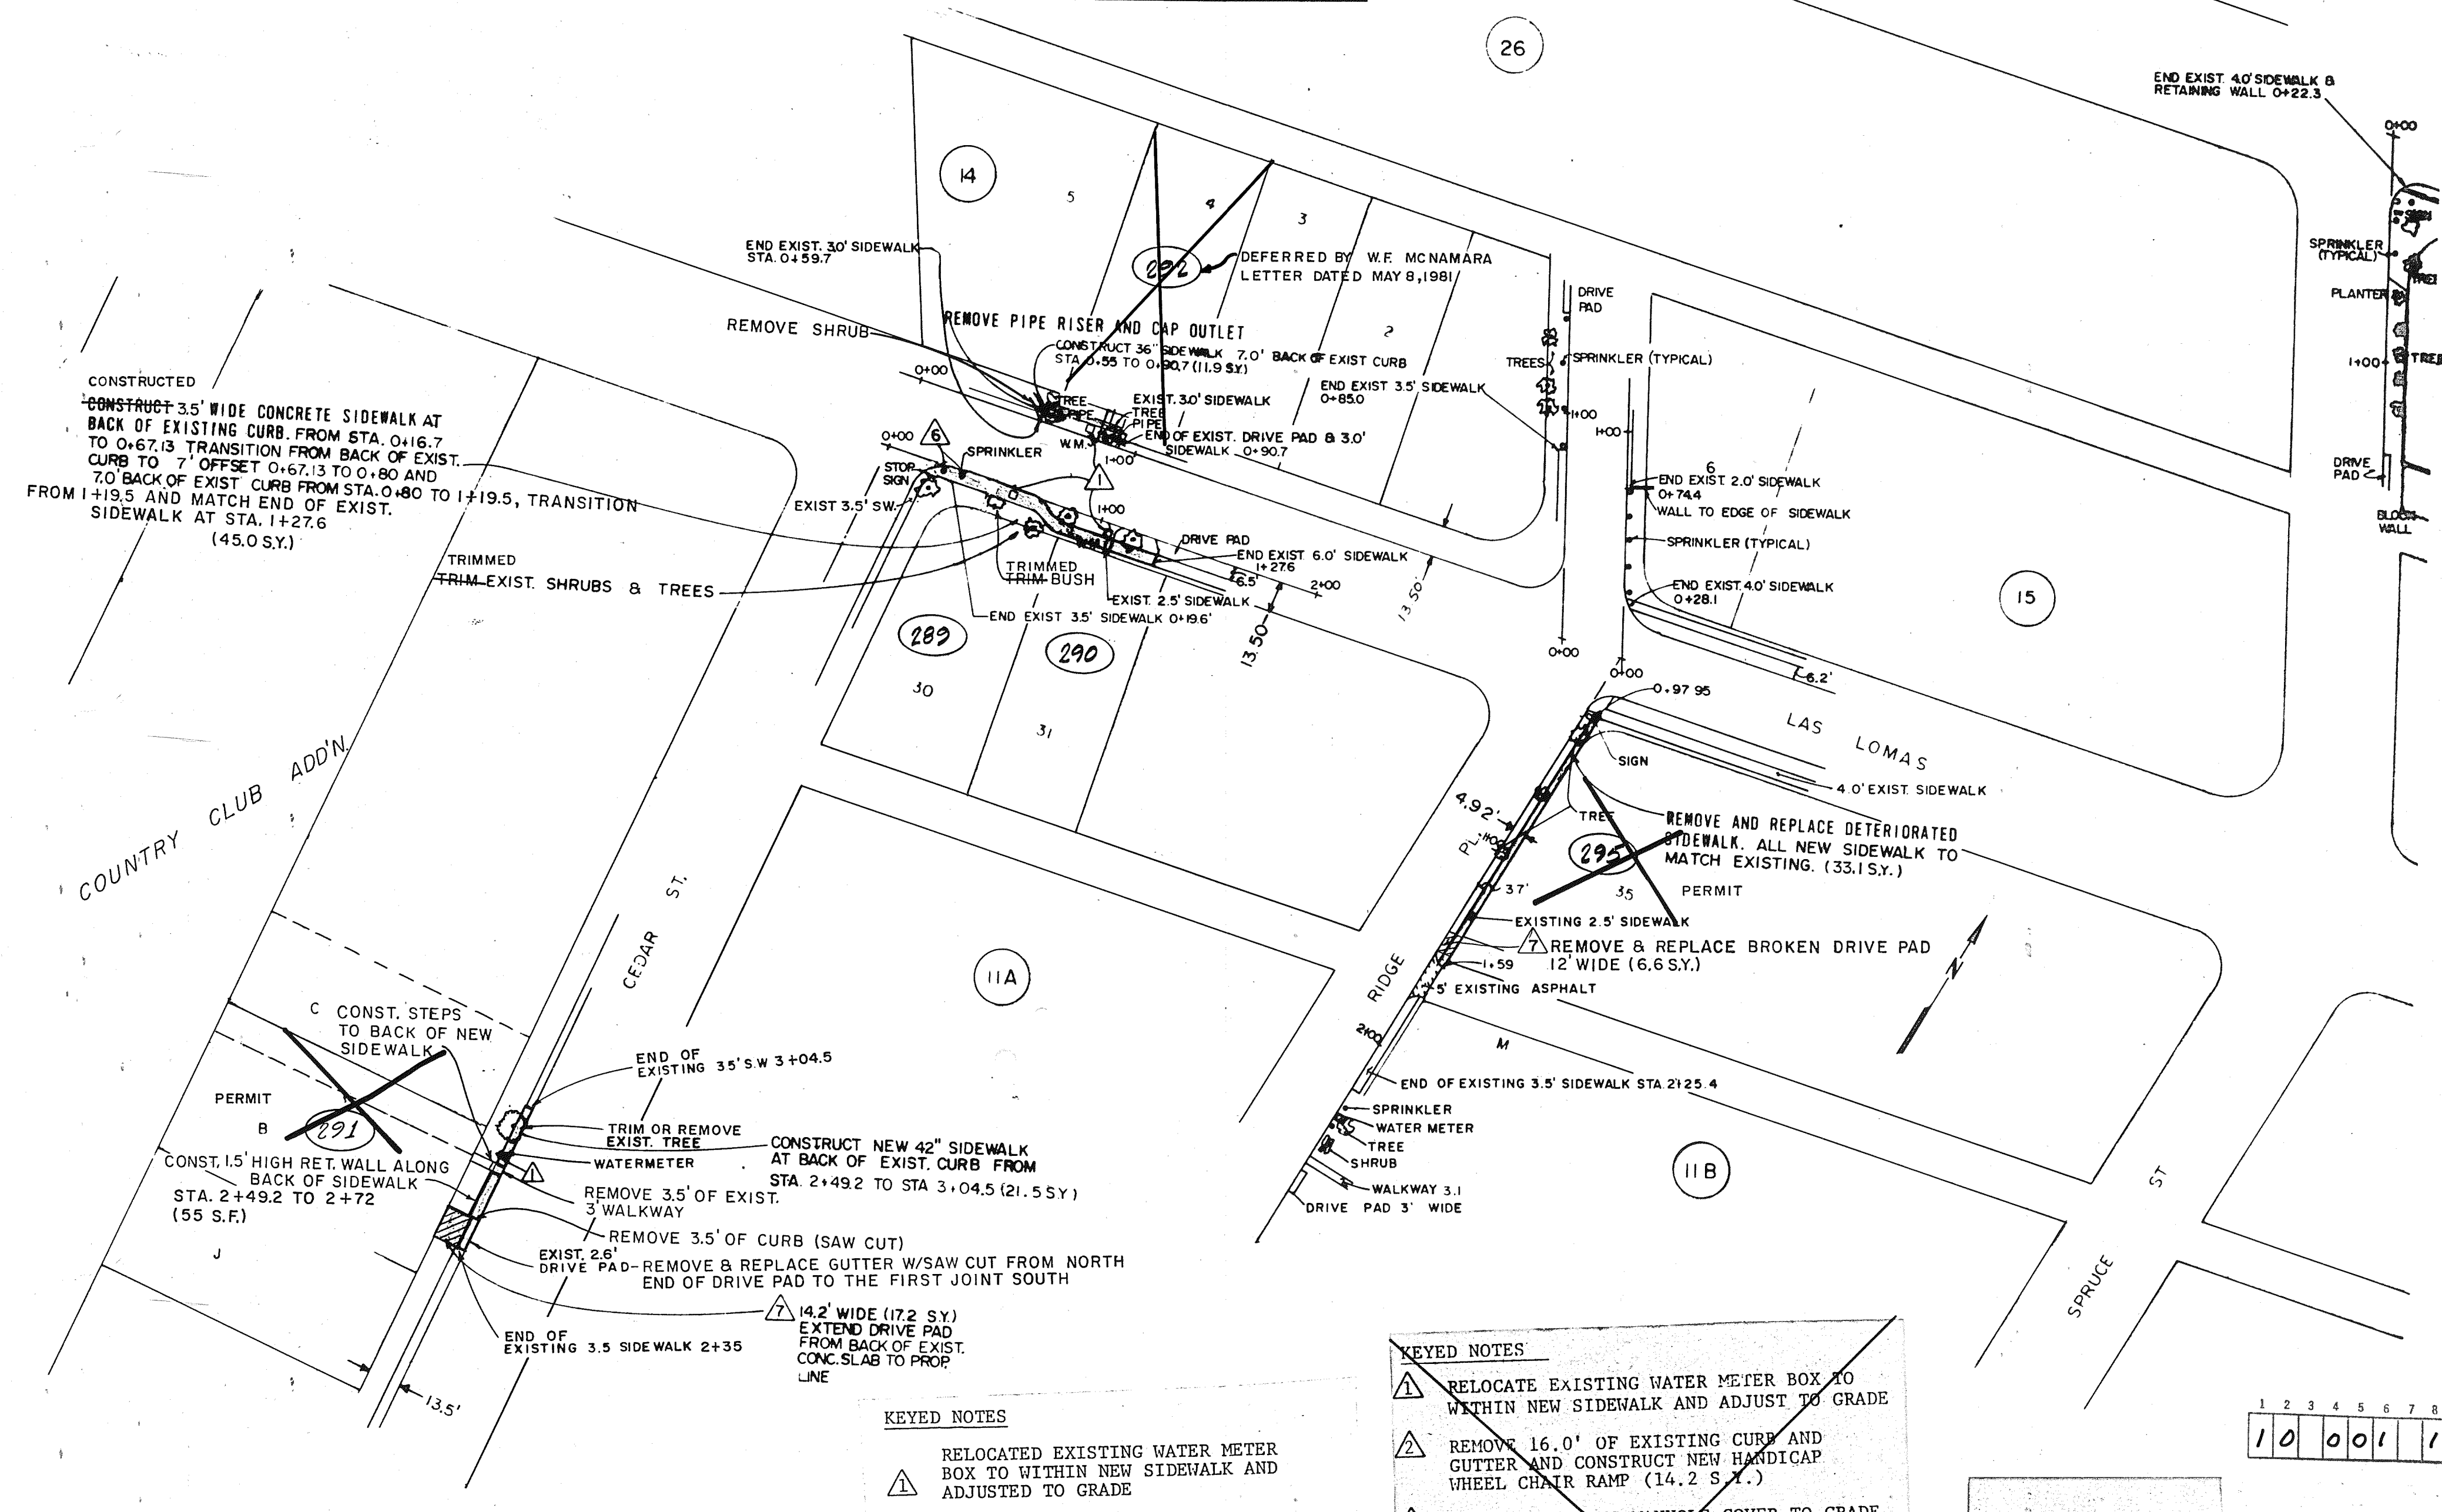[illegible]

CITY OF ALBUQUERQUE MUNICIPAL DEVELOPMENT DEPARTMENT ENGINEERING DIVISION					
TITLE SIDEWALK & CURB & GUTTER IMPROVEMENT DISTRICT NO. 5 CEDAR ST.N.E., LAS LOMAS RD.N.E., RIDGE PL.N.E. MED-ART AVE., N.E.					
APPROVALS	ENGINEER	DATE	APPROVALS	ENGINEER	DATE
City Engineer			Liquid Waste		
A.C.E. Design			Traffic		
A.C.E. Hydrology			Water		
DRAWING NO.				SHEET 16 OF 18	

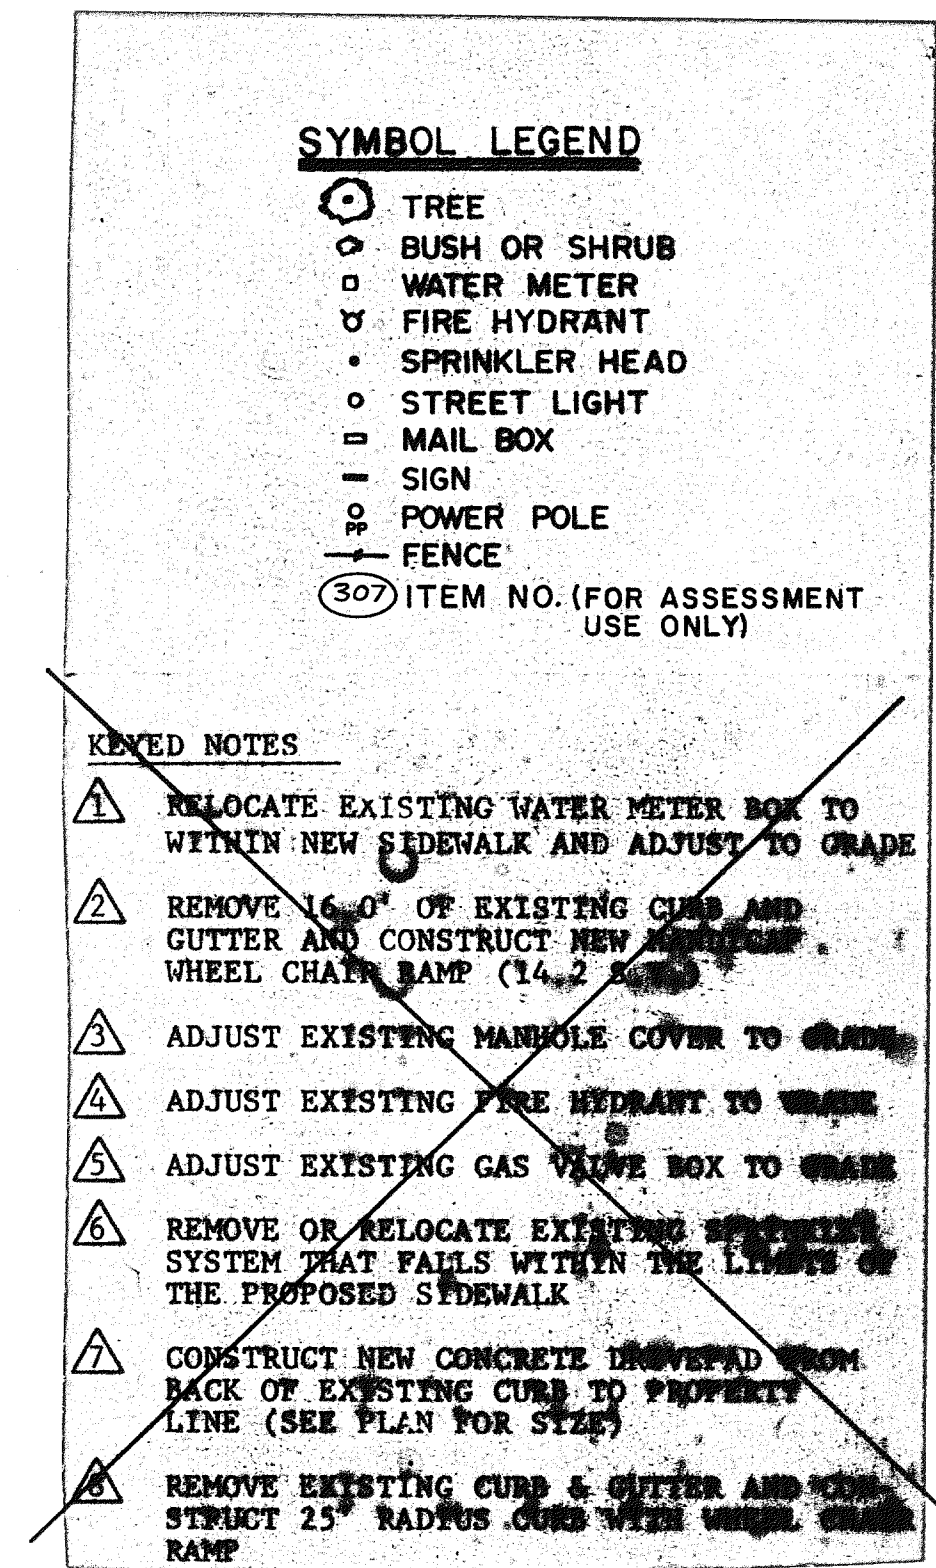

SCALE: 1" = 50'

KEYED NOTES

- ① RELOCATED EXISTING WATER METER BOX TO WITHIN NEW SIDEWALK AND ADJUSTED TO GRADE
- ② REMOVED EXISTING CURB AND GUTTER AND CONSTRUCTED NEW HANDICAP WHEEL CHAIR RAMP
- ③ REMOVED OR RELOCATED EXISTING SPRINKLER SYSTEM THAT FALLS WITHIN THE LIMITS OF THE PROPOSED SIDEWALK
- ④ CONSTRUCTED NEW CONCRETE DRIVEPAD
- ⑤ REMOVED EXISTING CURB AND GUTTER AND CONSTRUCTED 25' RADIUS CURB WITH WHEEL CHAIR RAMP

AS BUILT








1	2	3	4	5	6	7	8	9	10	11	12
1	0		0	0	1			1	7	8	2

ROMA AVE. N.E., JOHN ST. N.E.


APPROVALS	ENGINEER	DATE	APPROVALS	ENGINEER	DATE
City Engineer			Liquid Waste		
A.C.E. Design			Traffic		
A.C.E. Hydrology			Water		

**DRAWING
NO.**

 SHEET 17 OF 18

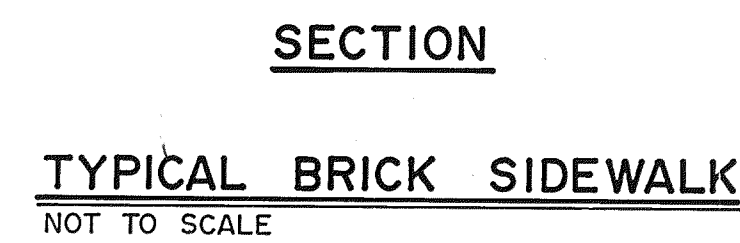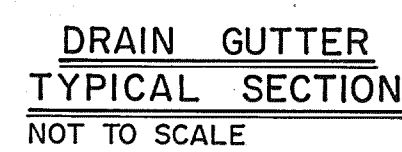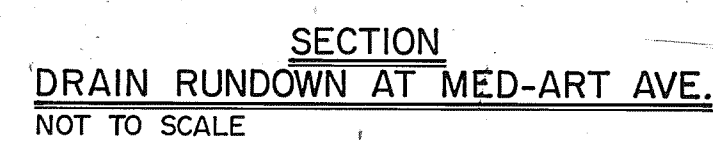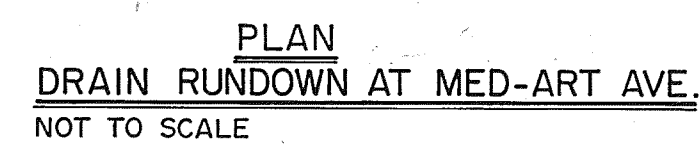

CITY OF ALBUQUERQUE MUNICIPAL DEVELOPMENT DEPARTMENT ENGINEERING DIVISION					
TITLE SIDEWALK & CURB & GUTTER IMPROVEMENT DISTRICT NO. 5					
DETAILS					
APPROVALS	ENGINEER	DATE	APPROVALS	ENGINEER	DATE
City Engineer			Liquid waste		
A.C.E. Design			Traffic		
A.C.E. Hydrology			Water		
DRAWING NO. _____			SHEET 18 OF 18		

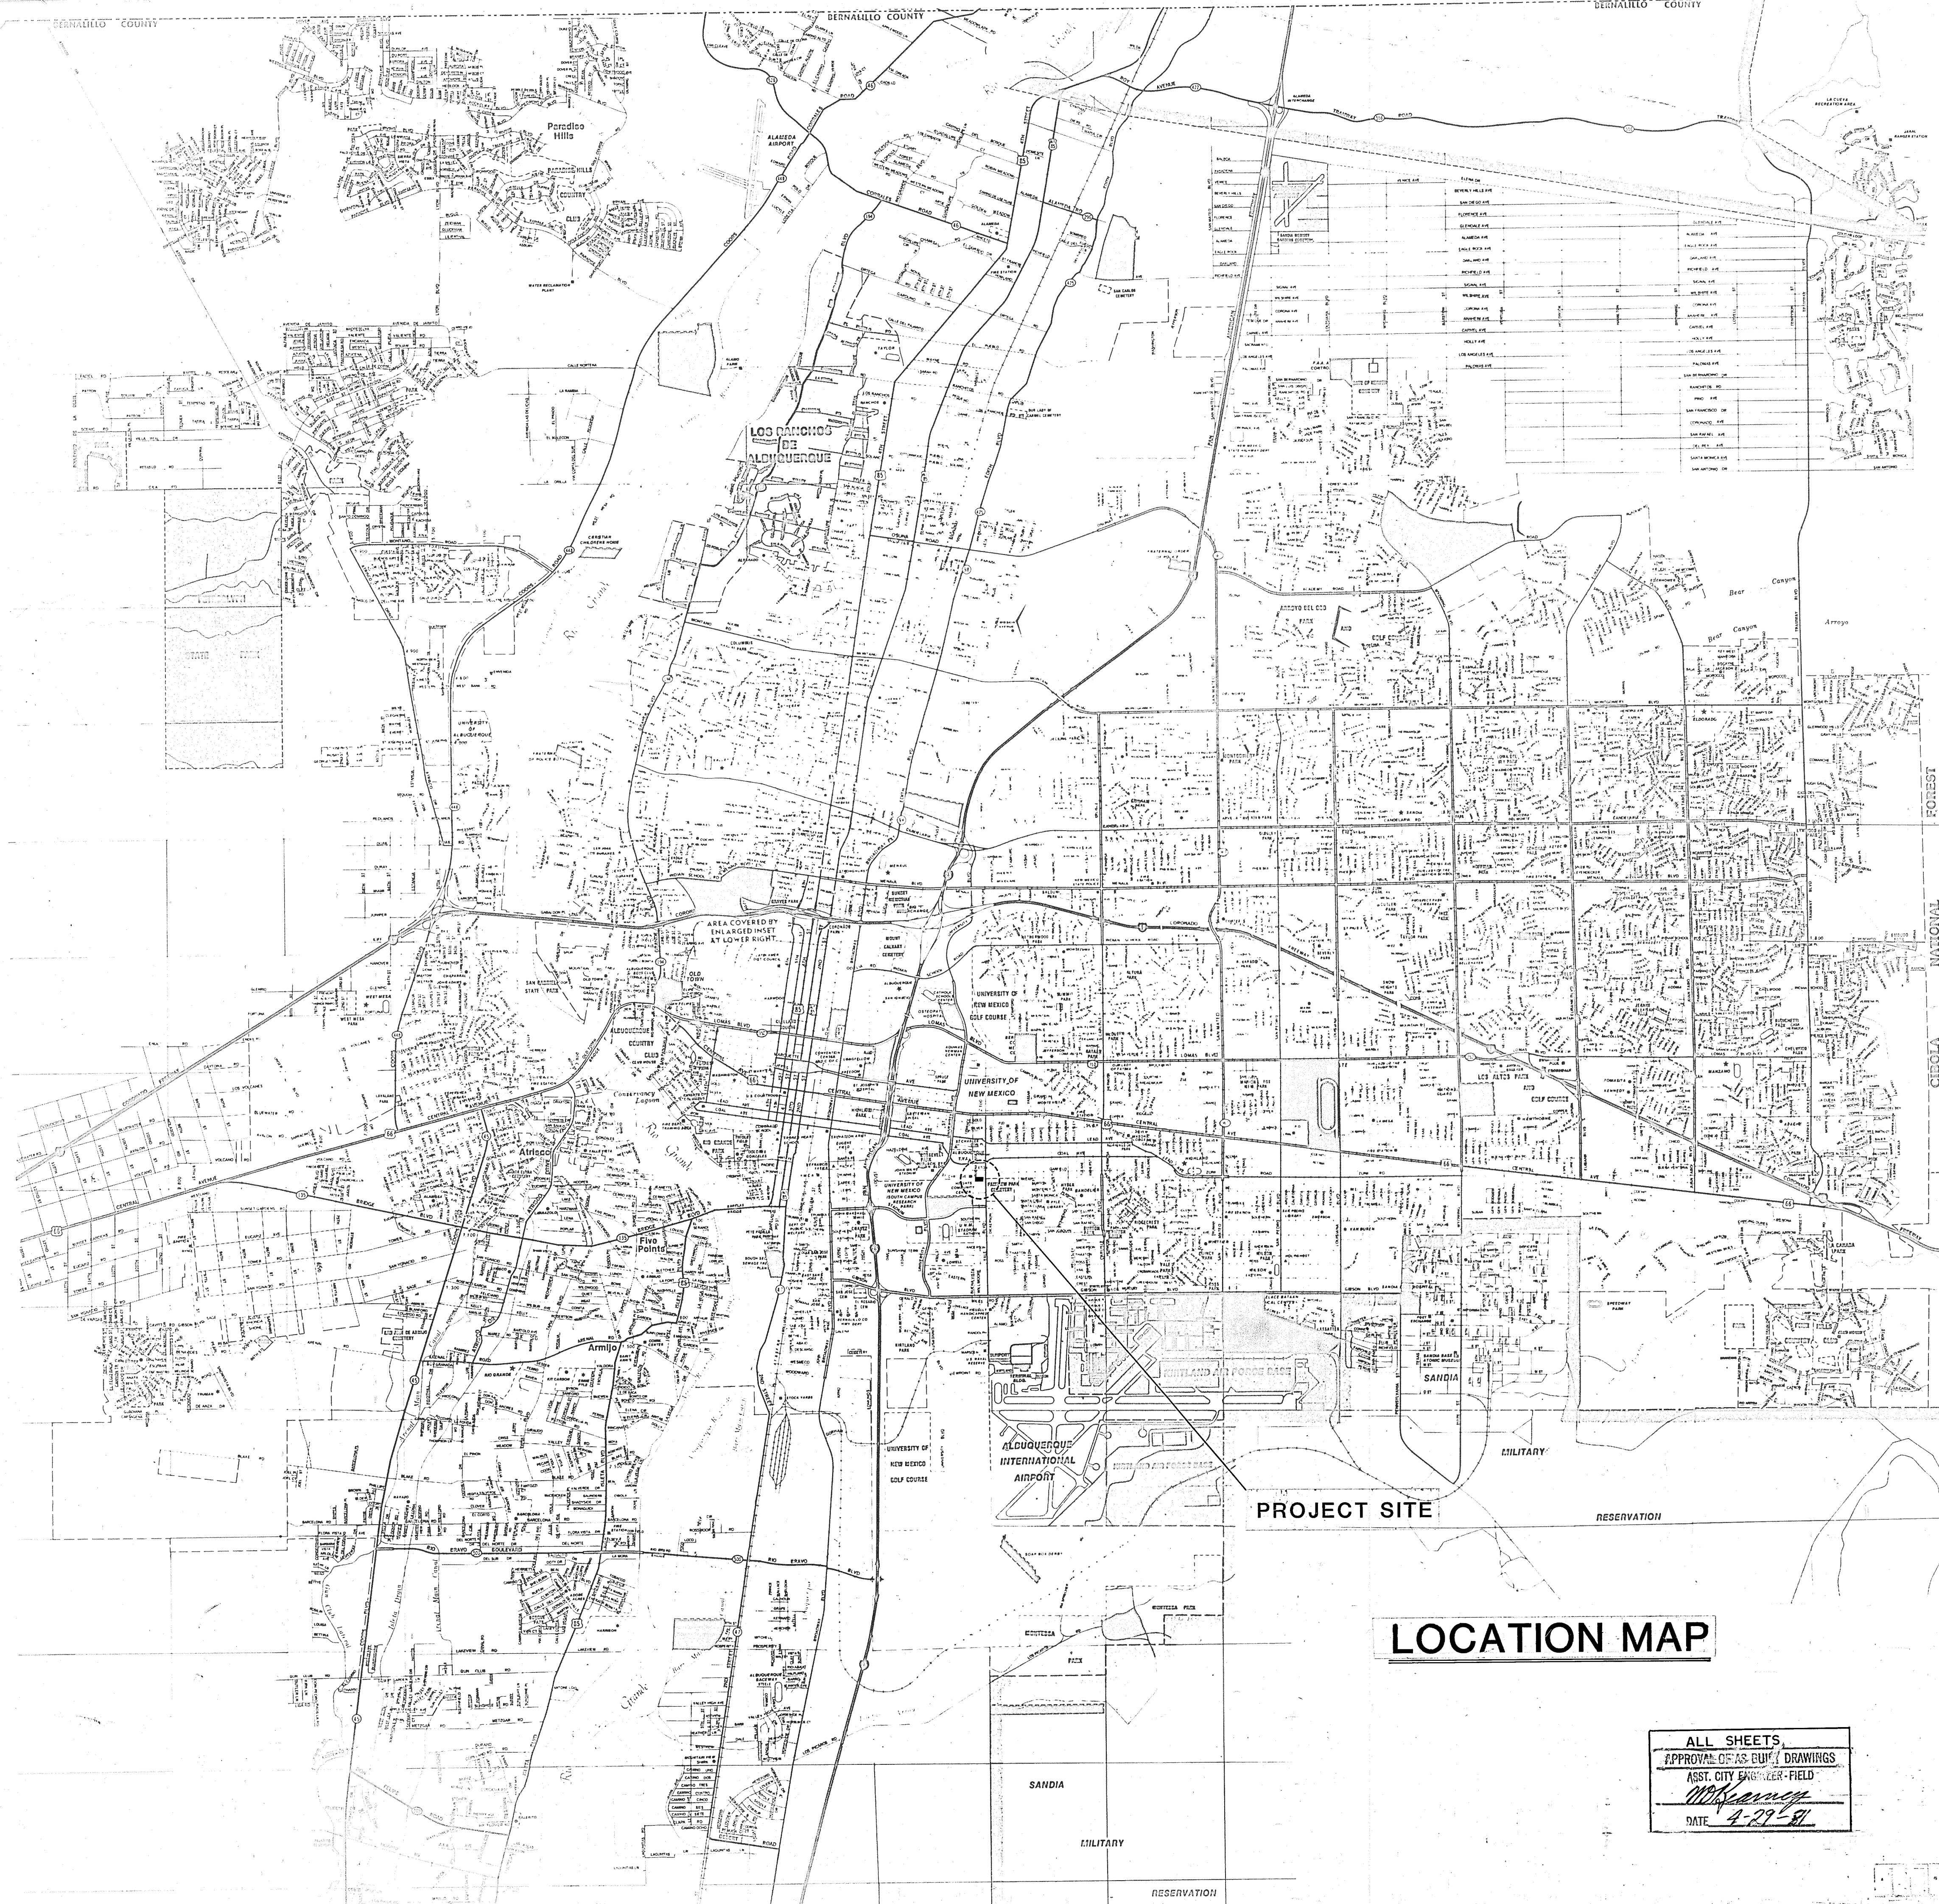

SUN-TRAN OFFICE REMODEL
601 YALE S.E.
CITY OF ALBUQUERQUE
ALBUQUERQUE, NEW MEXICO

INDEX TO DRAWINGS

- A-1 FLOOR PLAN**
- A-2 WALL SECTIONS, DETAILS, CONSTRUCTION NOTES**
- A-3 SCHEDULES, EXTERIOR DOOR & WINDOW DETAILS**
- A-4 INTERIOR DOOR & WINDOW DETAILS, MISC. DETAILS**
- A-5 SITE PLAN**

- M-1 MECHANICAL FLOOR PLAN**
- M-2 PLUMBING PLANS & SCHEDULE**

- E-1 LIGHTING FLOOR PLAN**
- E-2 POWER FLOOR PLAN**
- E-3 SCHEDULES & DIAGRAMS**

1 2 3 4 5 6 7 8 9 10 11 12
06 007 0181

DESIGN DATA

OCCUPANCY GROUP: B-2
TYPE OF CONSTRUCTION: IIIN
FIRE ZONE: 3

LEGAL DESCRIPTION

TRACT B PLAT OF LANDS OF M. ROBERT KLEBANOFF

AS-BUILT 2/6/81

Richard C. Smith

LOCATION MAP

ALL SHEETS
APPROVAL OF AS-BUILT DRAWINGS
ASST. CITY ENGINEER-FIELD
McKamoy
DATE 4-22-81