


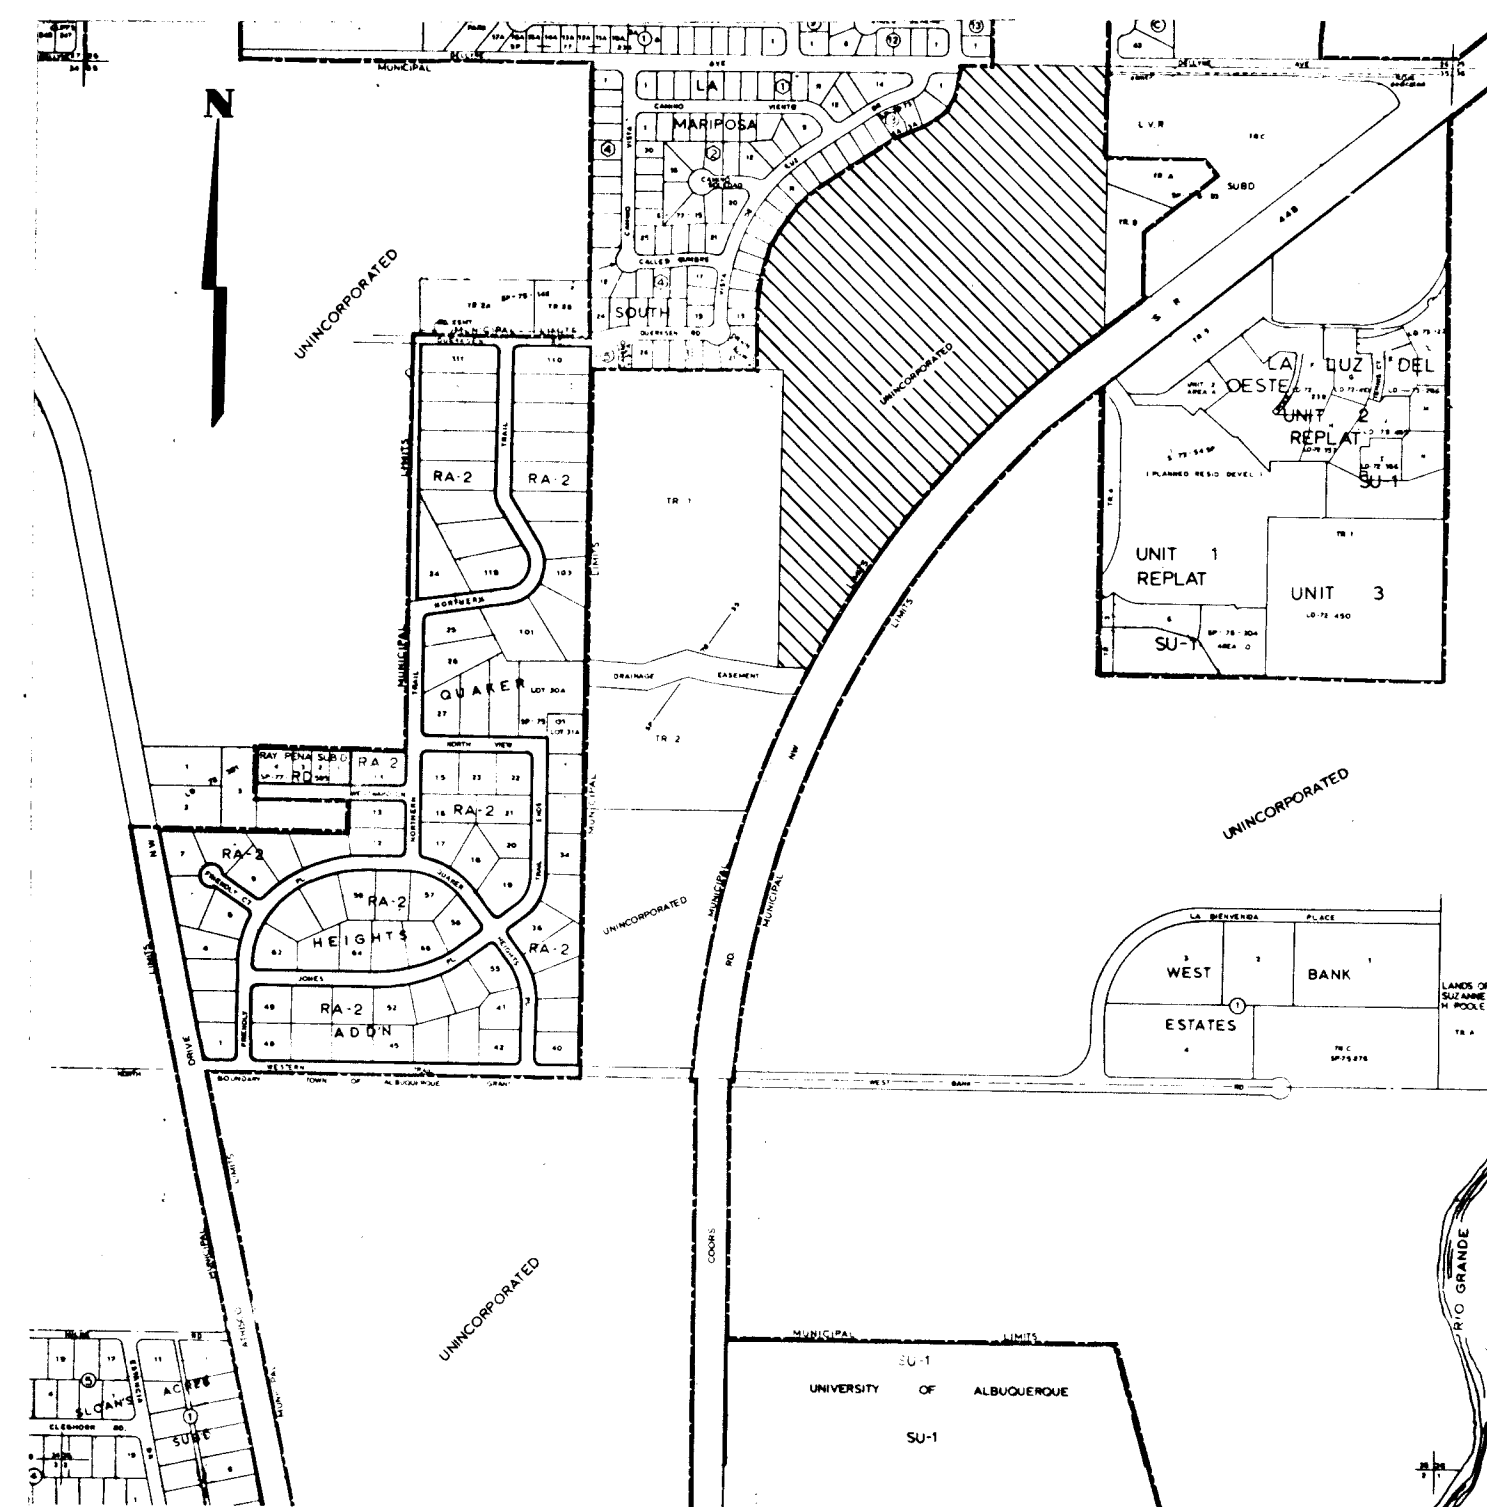

VICINITY MAP No. F-11



LA LUZ DEL OESTE

UNIT - 4 PHASE III

INDEX

DESCRIPTION	SHEET NO.
TITLE SHEET & CONSTRUCTION LAYOUT	1-2
DETAILS	3
GRADING PLAN	4
PAVING LAYOUT	5
WATER LAYOUT	6
PLAN & PROFILE - PAVING & WATER	7
ROAD PROFILES	8

APPROVED FOR WATER LINE CONSTRUCTION
PHASE - III / <i>D. Monahan</i> 10/1/81
<i>Richard S. Haller</i> 10/1/81

R.S. Haller
 CITY ENGINEER - CITY OF ALBUQUERQUE, NEW MEXICO
 Approved for drainage, grading &
 PUBLIC WATER SYSTEM ONLY


7/11/79
 DATE

J.J. Bordenave
 J.J. BORDENAVE, N.M.P.E. & L.S. NO. 5110

7/6/79
 DATE

T.T. Burnett Engineering, Inc.
 120 Morningside N.E.
 Albuquerque, New Mexico



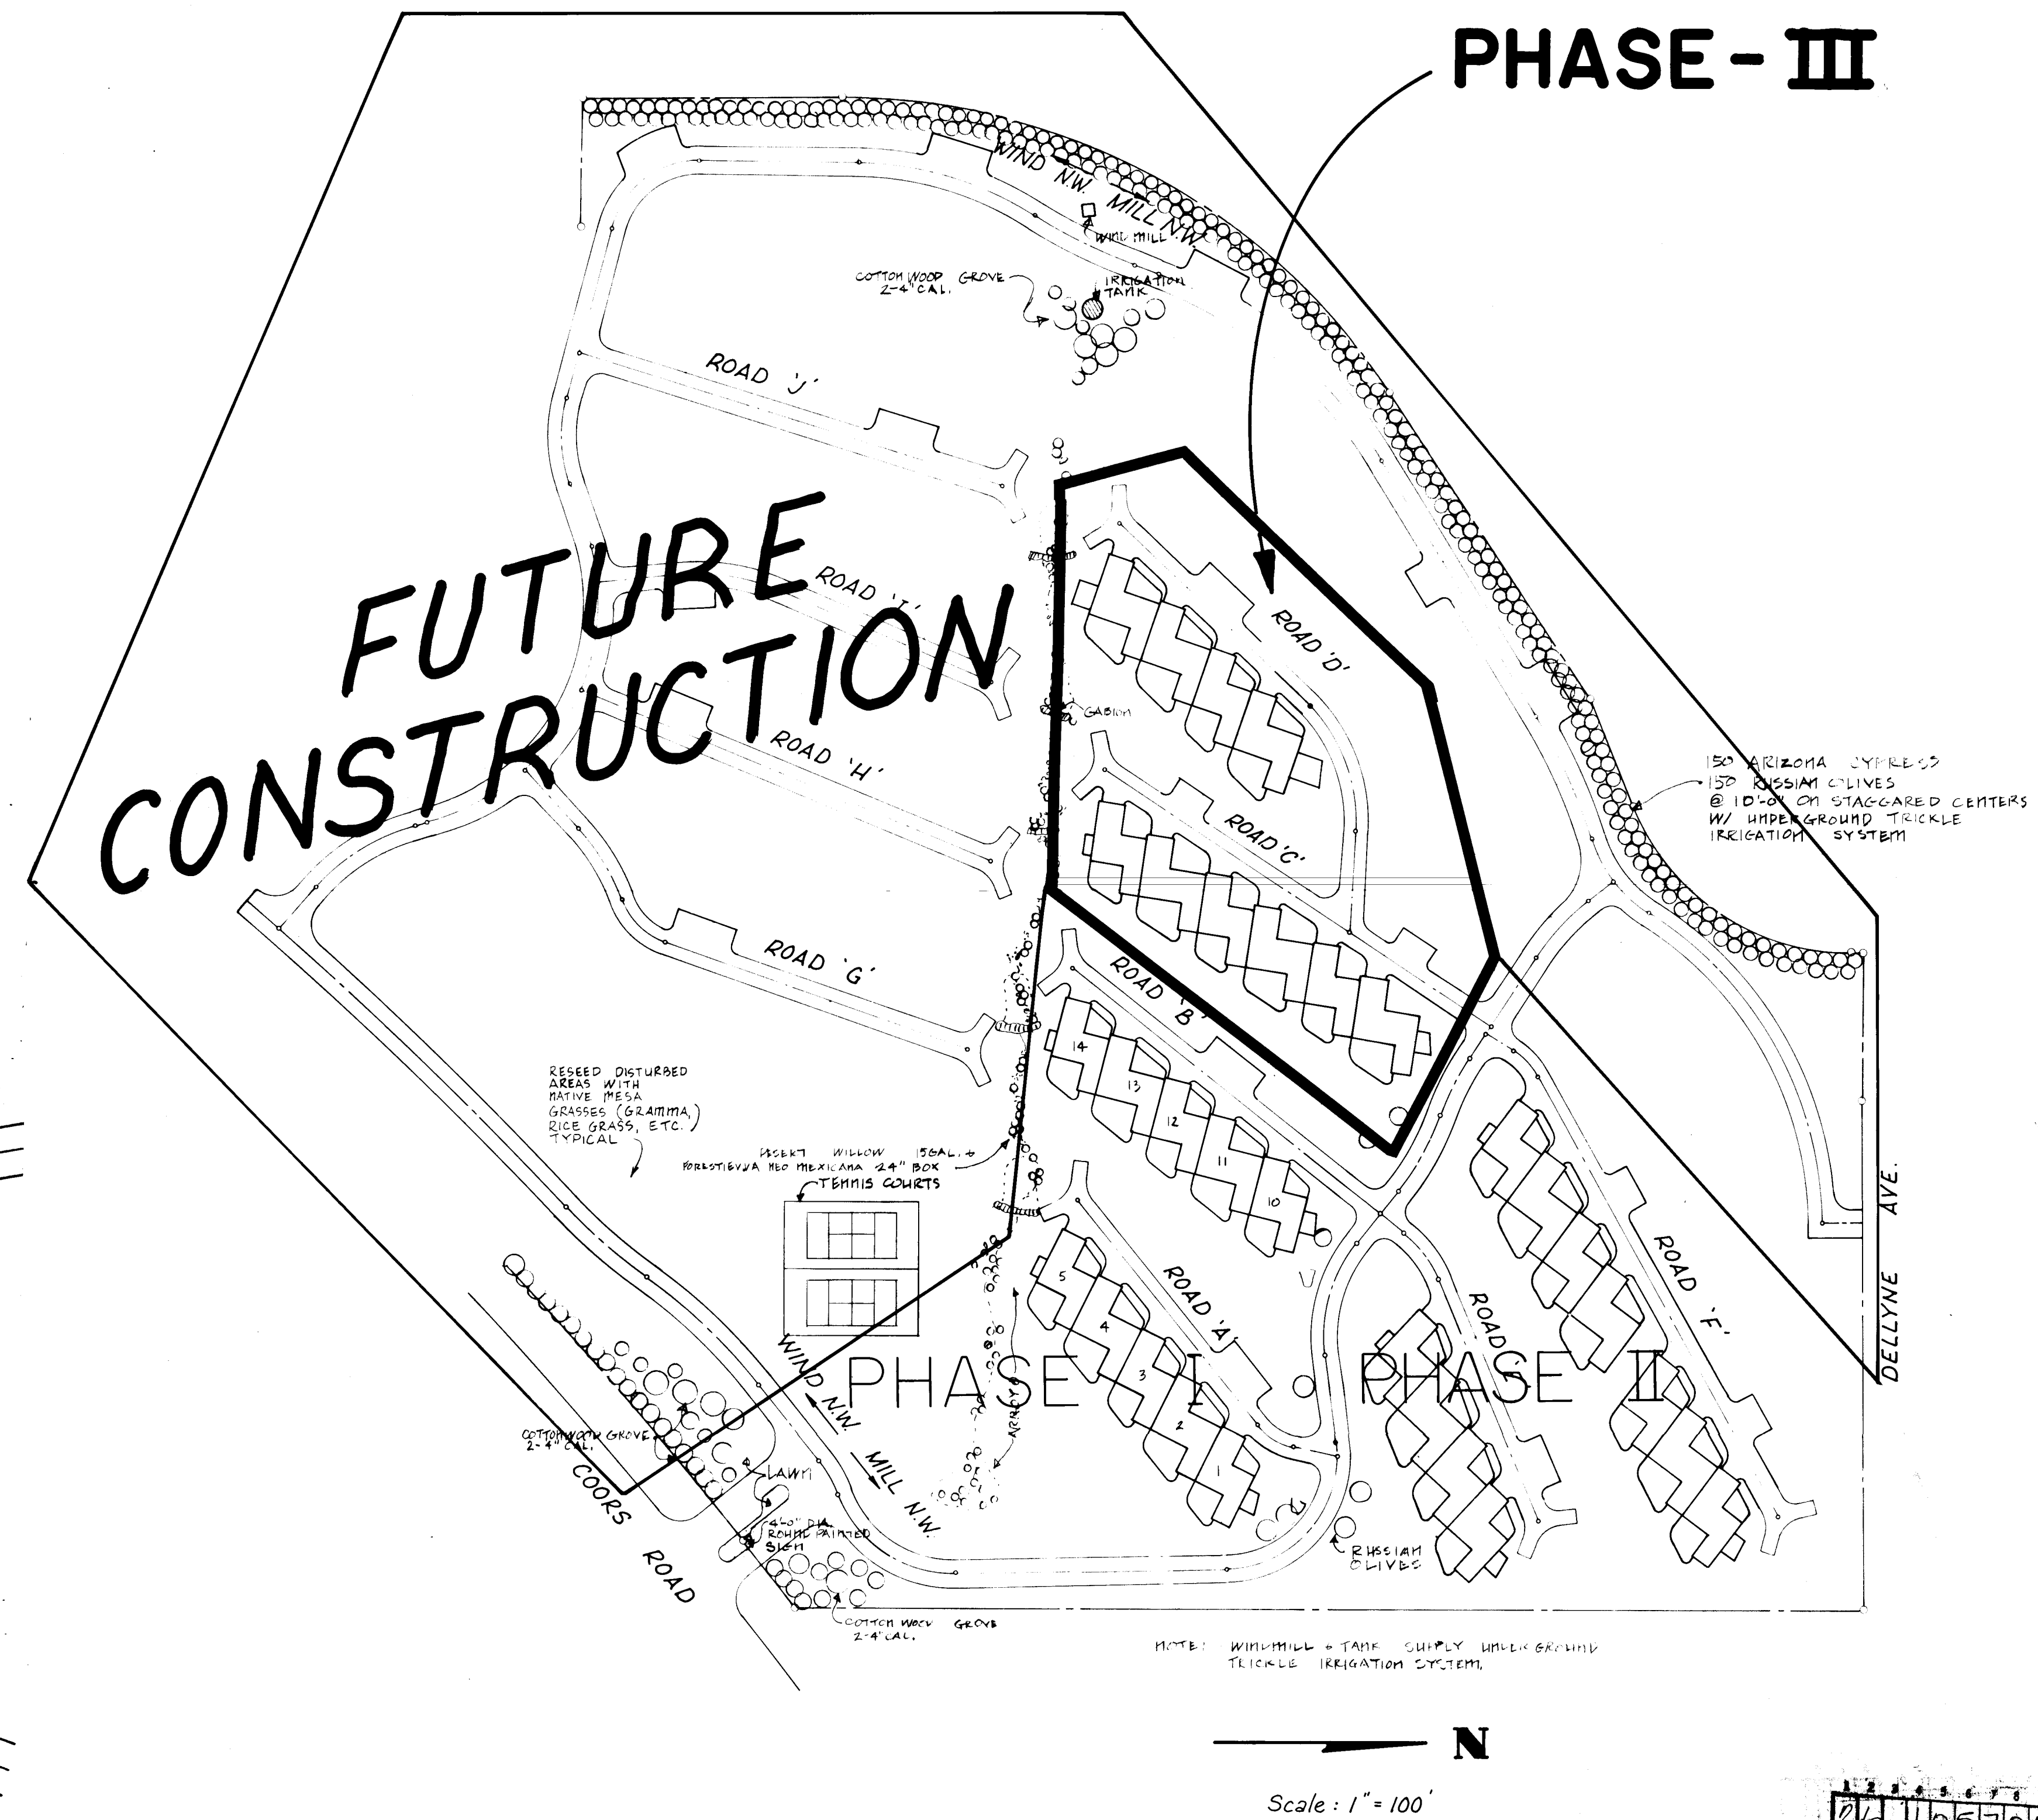

A stylized map showing a road network with the text "FUTURE CONSTRUCTION" overlaid in large, bold, black letters. The map features several roads, with two labeled "ROAD 'I'" and "ROAD 'H'". The text is written in a thick, hand-drawn style, slanted upwards from left to right. The background is white with black lines representing the roads.

PHASE I PHASE

NOTE: WINDMILL & TANK SUPPLY UNDER GROUND
TRICKLE IRRIGATION SYSTEM.

Scale : 1" = 100'

1	2	3	4	5	6	7	8	9	10	11	12
26		1	0	5	7	0	2	8	2		

CITY OF ALBUQUERQUE
PUBLIC WORKS DEPARTMENT
ENGINEERING DIVISION

LA LUZ DEL OESTE UNIT 4
CONSTRUCTION LAYOUT

PAGE 2 OF 8

[illegible]



ELEVATION	N.A.S.	F-#	A.D.M.C.
DATE OF SURVEY	SHEET NO.	NO.	BY DATE
CORREL INFORMATION			
BENCH MARKS	<i>NM 448-Ng Elev 5058.89 NM5HC Brass tablet on the South side of State Road 448 (Coors Road NW) in the entrance to the La Luz Condominium.</i>		
PLOT INFORMATION	WATER PLANTING BY CONNECTED B.		
MICRO-FILM INFORMATION			
REC. HOTEL #	DATE		

NO. DATE	REMARKS	BY
 DESIGNED BY T T BURNETT ENGINEERING INC. 120 MORNINGSIDE DRIVE N.E. ALBUQUERQUE, NEW MEXICO 87108 DATE		
REVISIONS BY		


1	2	3	4	5	6	7	8	9	10	11	12
26			1	0	5	7	0	3	8	2	

CITY OF ABERDEEN PUBLIC WORKS DEPARTMENT ENGINEERING DIVISION					
TITLE LA LUZ DEL OESTE UNIT 4 DETAILS - PHASE III					
APPROVAL	ENGINEER	DATE	APPROVAL	ENGINEER	DATE
City Engineer			Liquid Waste	NA	10/26/78
A.C.E. Design	<i>[Signature]</i>	6/6/78	Traffic	<i>[Signature]</i>	7/11/78
A.C.E. Hydrology	<i>[Signature]</i>	7/6/78	Water	NA	10/26/78
DRAWING NO. 1057			SHEET 3 OF 8		



APPROVED FOR
CONSTRUCTION

CITY ENGINEER DATE


CITY OF ALBUQUERQUE PUBLIC WORKS DEPARTMENT ENGINEERING DIVISION					
TITLE:					
APPROVALS	ENGINEER	DATE	APPROVALS	ENGINEER	DATE
City Engineer	<i>[Signature]</i>	<i>7/1/75</i>	Liquid Waste		
A.C.E. Design			Traffic	N.A.	
A.C.E. Hydrology			Water		
DRAWING NO.			SHEET OF		
APPROVED FOR CONSTRUCTION					
CITY ENGINEER	DATE				

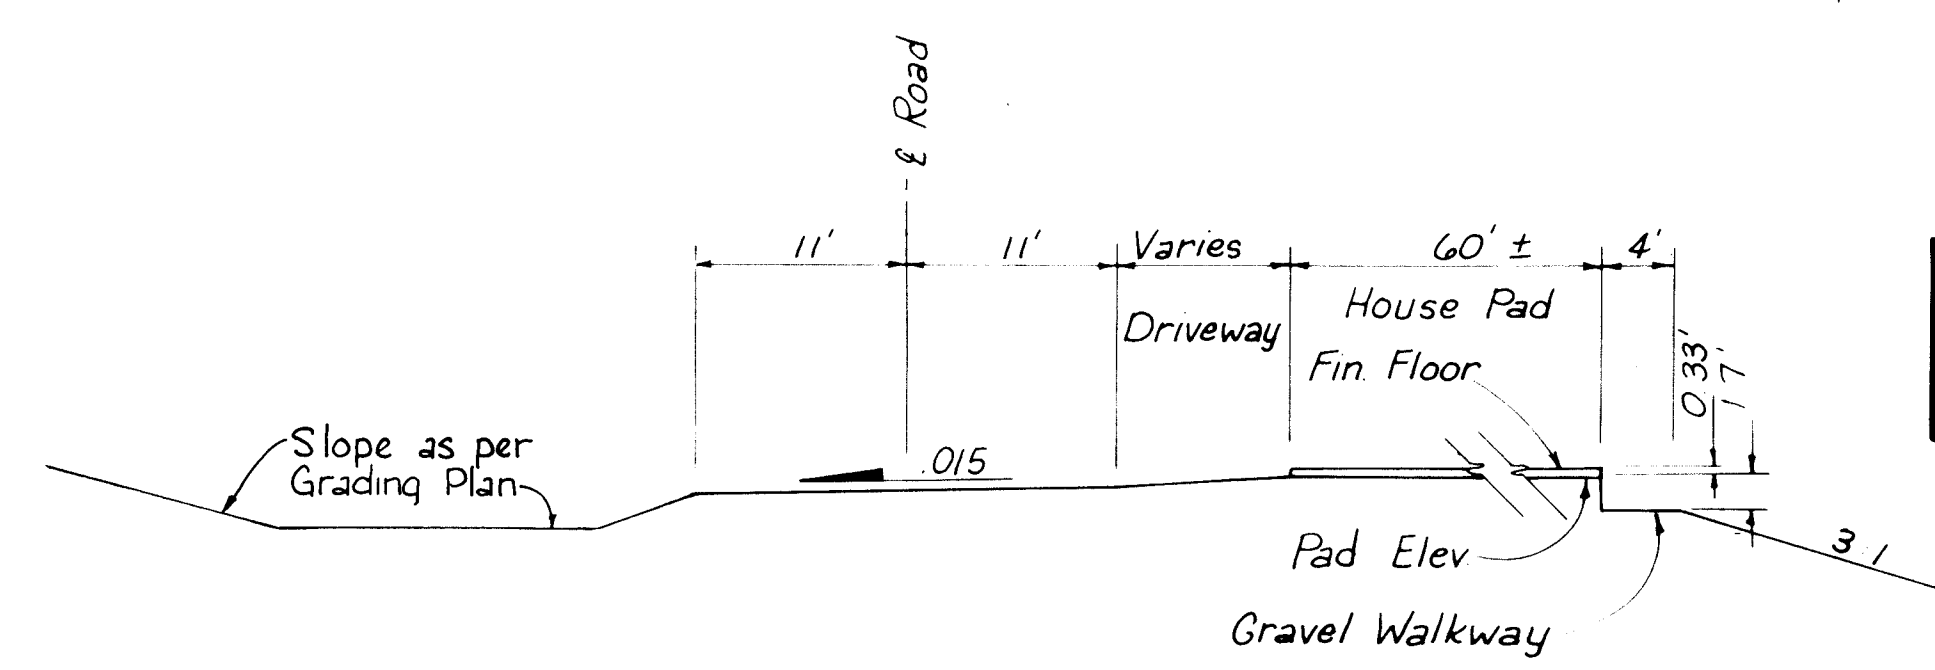

GRADING: HOUSE PAD & 22' STREET

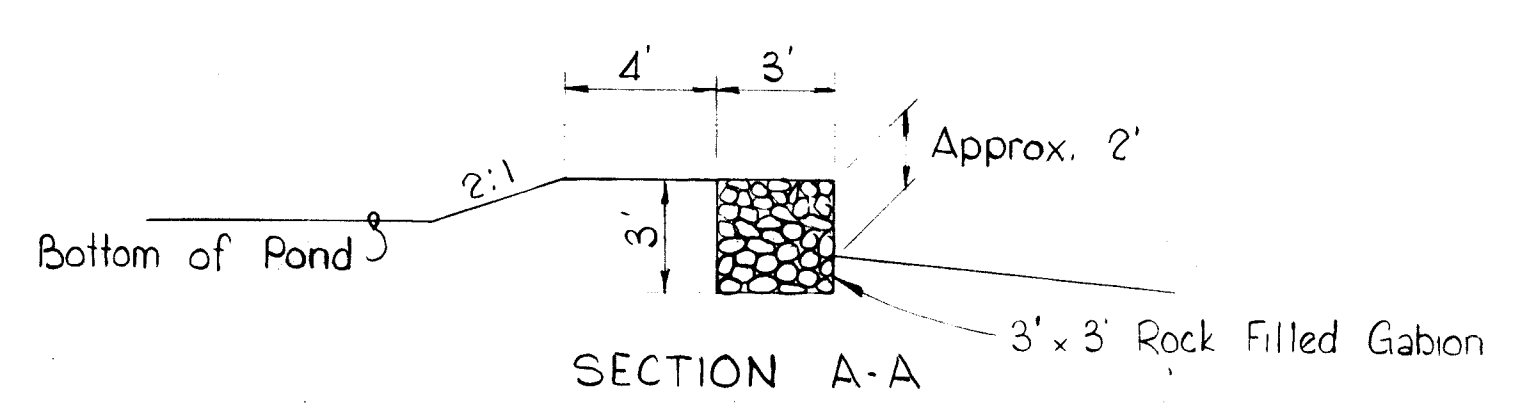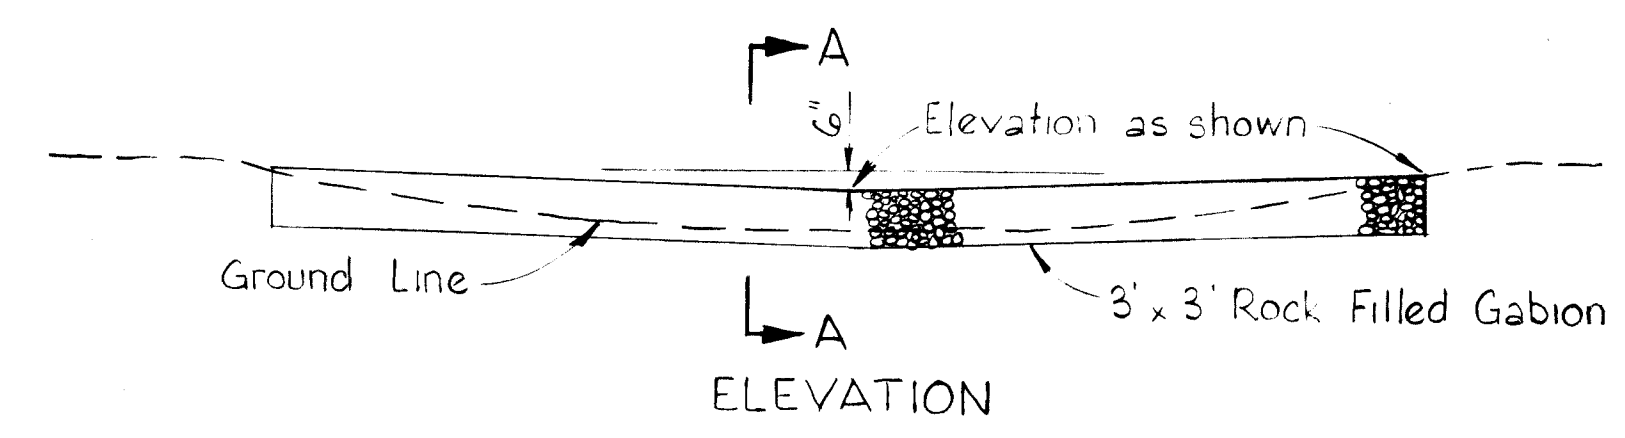

PHASE - III

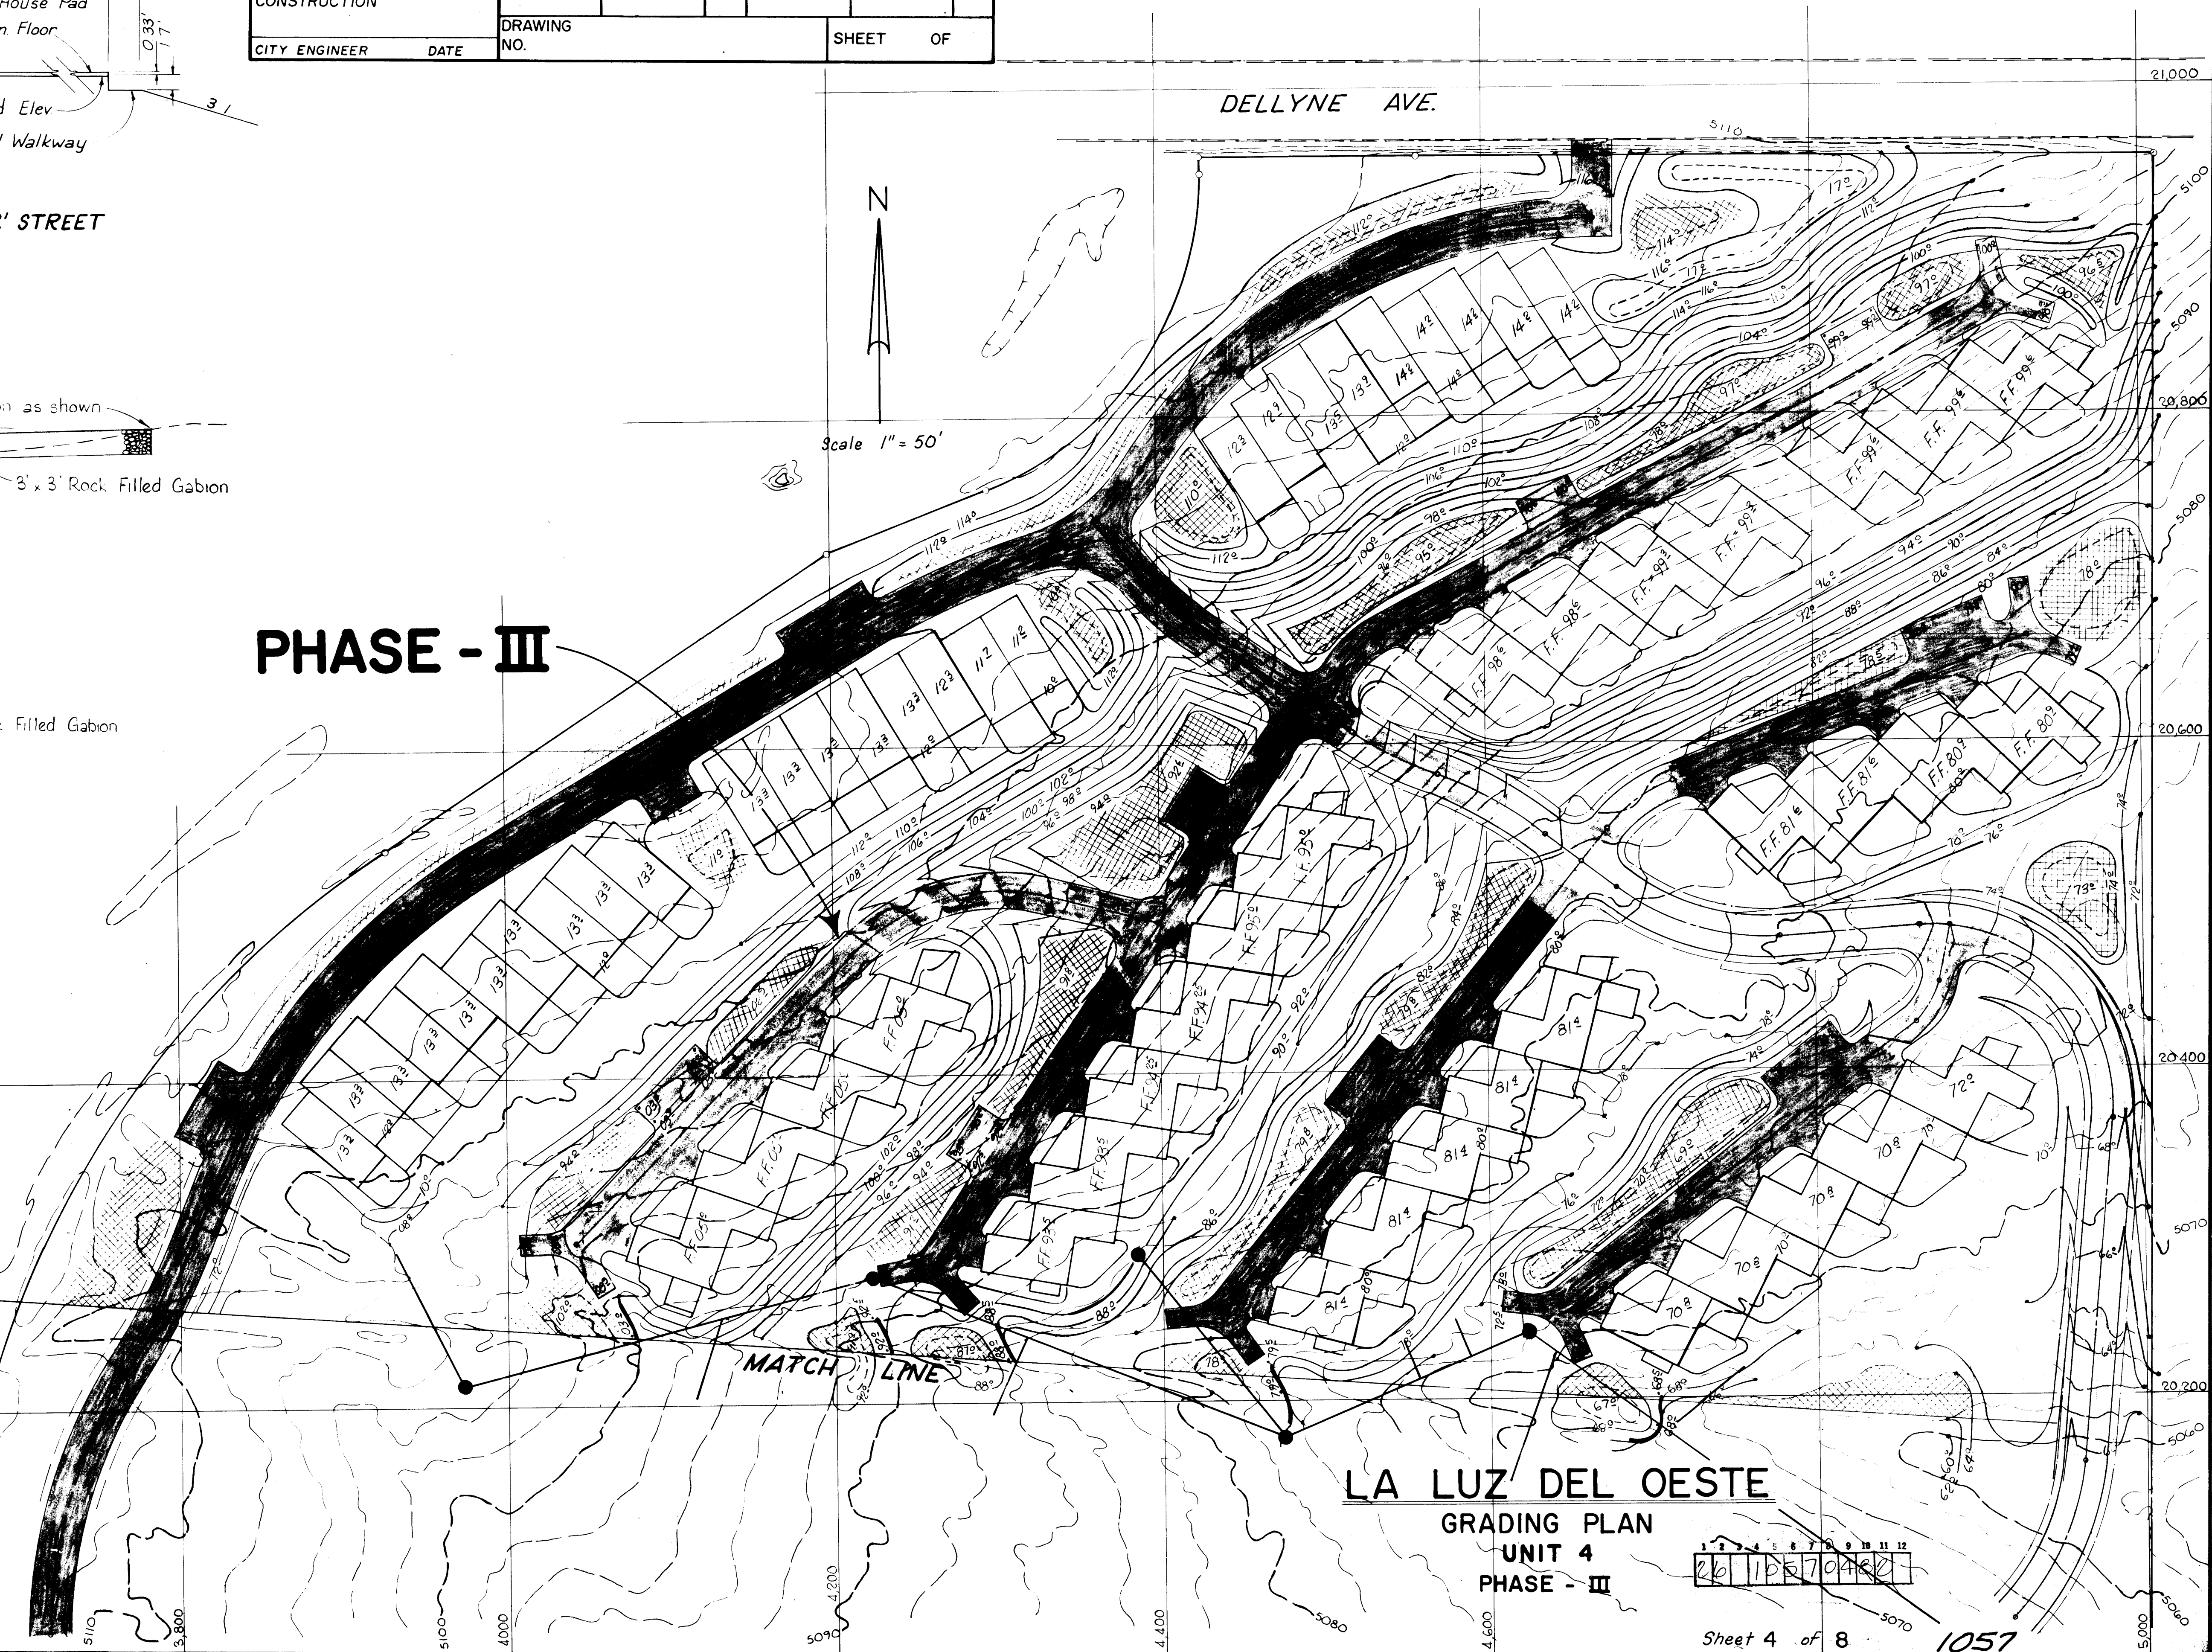

LA LUZ DEL OESTE
GRADING PLAN
UNIT 4
PHASE - III

1	2	3	4	5	6	7	8	9	10	11	12
26	16	6	7	9	4	8					



REVISIONS

Revised grade on Mill Road, 2-22-80
See sheet 9 of 12.

Revised grades on Roads A, B & E, 2-22-80
See sheet 11 of 12.

CURVE DATA

CURVE NO.	RADIUS	ARC	CHORD	DELTA	TANGENT
C 1	210.00'	69.64'	69.32'	19°00'00"	35.14'
C 2	230.02'	57.62'	57.47'	14°21'07"	26.96'
C 3	230.02'	77.69'	77.38'	19°21'07"	39.22'
C 4	125.00'	100.36'	97.68'	46°00'00"	53.06'
C 5	100.00'	169.30'	149.79'	92°00'00"	113.03'
C 6	110.00'	132.56'	124.79'	69°05'55"	75.74'
C 7	110.00'	33.29'	33.17'	13°20'29"	16.77'
C 8	180.00'	106.81'	105.25'	34°00'00"	55.03'
C 9	200.00'	331.61'	294.91'	95°00'00"	218.26'
C10	130.00'	77.14'	76.02'	34°00'00"	39.75'
C11	80.00'	106.12'	98.51'	76°00'00"	62.50'
C12	300.00'	167.55'	165.38'	32°00'00"	86.02'
C13	475.00'	99.48'	99.30'	12°00'00"	49.92'
C14	400.00'	265.29'	260.45'	38°00'00"	137.73'
C15	490.00'	119.73'	119.43'	14°00'00"	60.16'
C16	119.74'	83.59'	81.91'	40°00'00"	43.58'
C17	327.96'	327.82'	314.35'	57°16'19"	179.08'
C18	56.00'	38.12'	37.39'	39°00'00"	19.83'
C19	150.00'	130.90'	126.79'	50°00'00"	69.05'
C20	80.00'	40.49'	40.06'	29°00'00"	20.69'
C21	65.00'	31.77'	31.45'	28°00'00"	16.21'
C22	190.00'	72.95'	72.51'	22°00'00"	36.93'
C23	65.00'	56.72'	54.94'	50°00'00"	30.31'
C24	180.00'	91.11'	90.14'	29°00'00"	46.55'
C 3	229.96'	76.45'	76.10'	19°02'56"	38.58'
C 4	145.00'	108.31'	105.81'	42°42'47"	56.82'
C 5	110.00'	190.06'	167.29'	98°59'53"	128.79'
C 6	152.92'	106.83'	104.68'	40°01'43"	55.70'
C18	41.72'	28.40'	27.85'	39°00'00"	14.77'
C19	125.00'	130.90'	125.00'	60°00'00"	72.17'
C 2	230.02'	32.69'	32.66'	8°08'31"	16.37'
C 3	122.00'	27.34'	27.28'	12°50'20"	13.73'

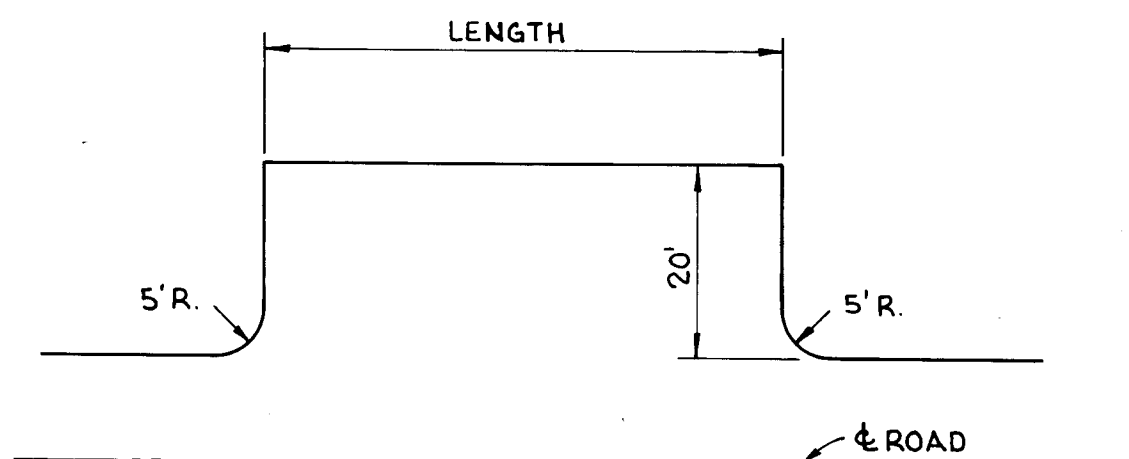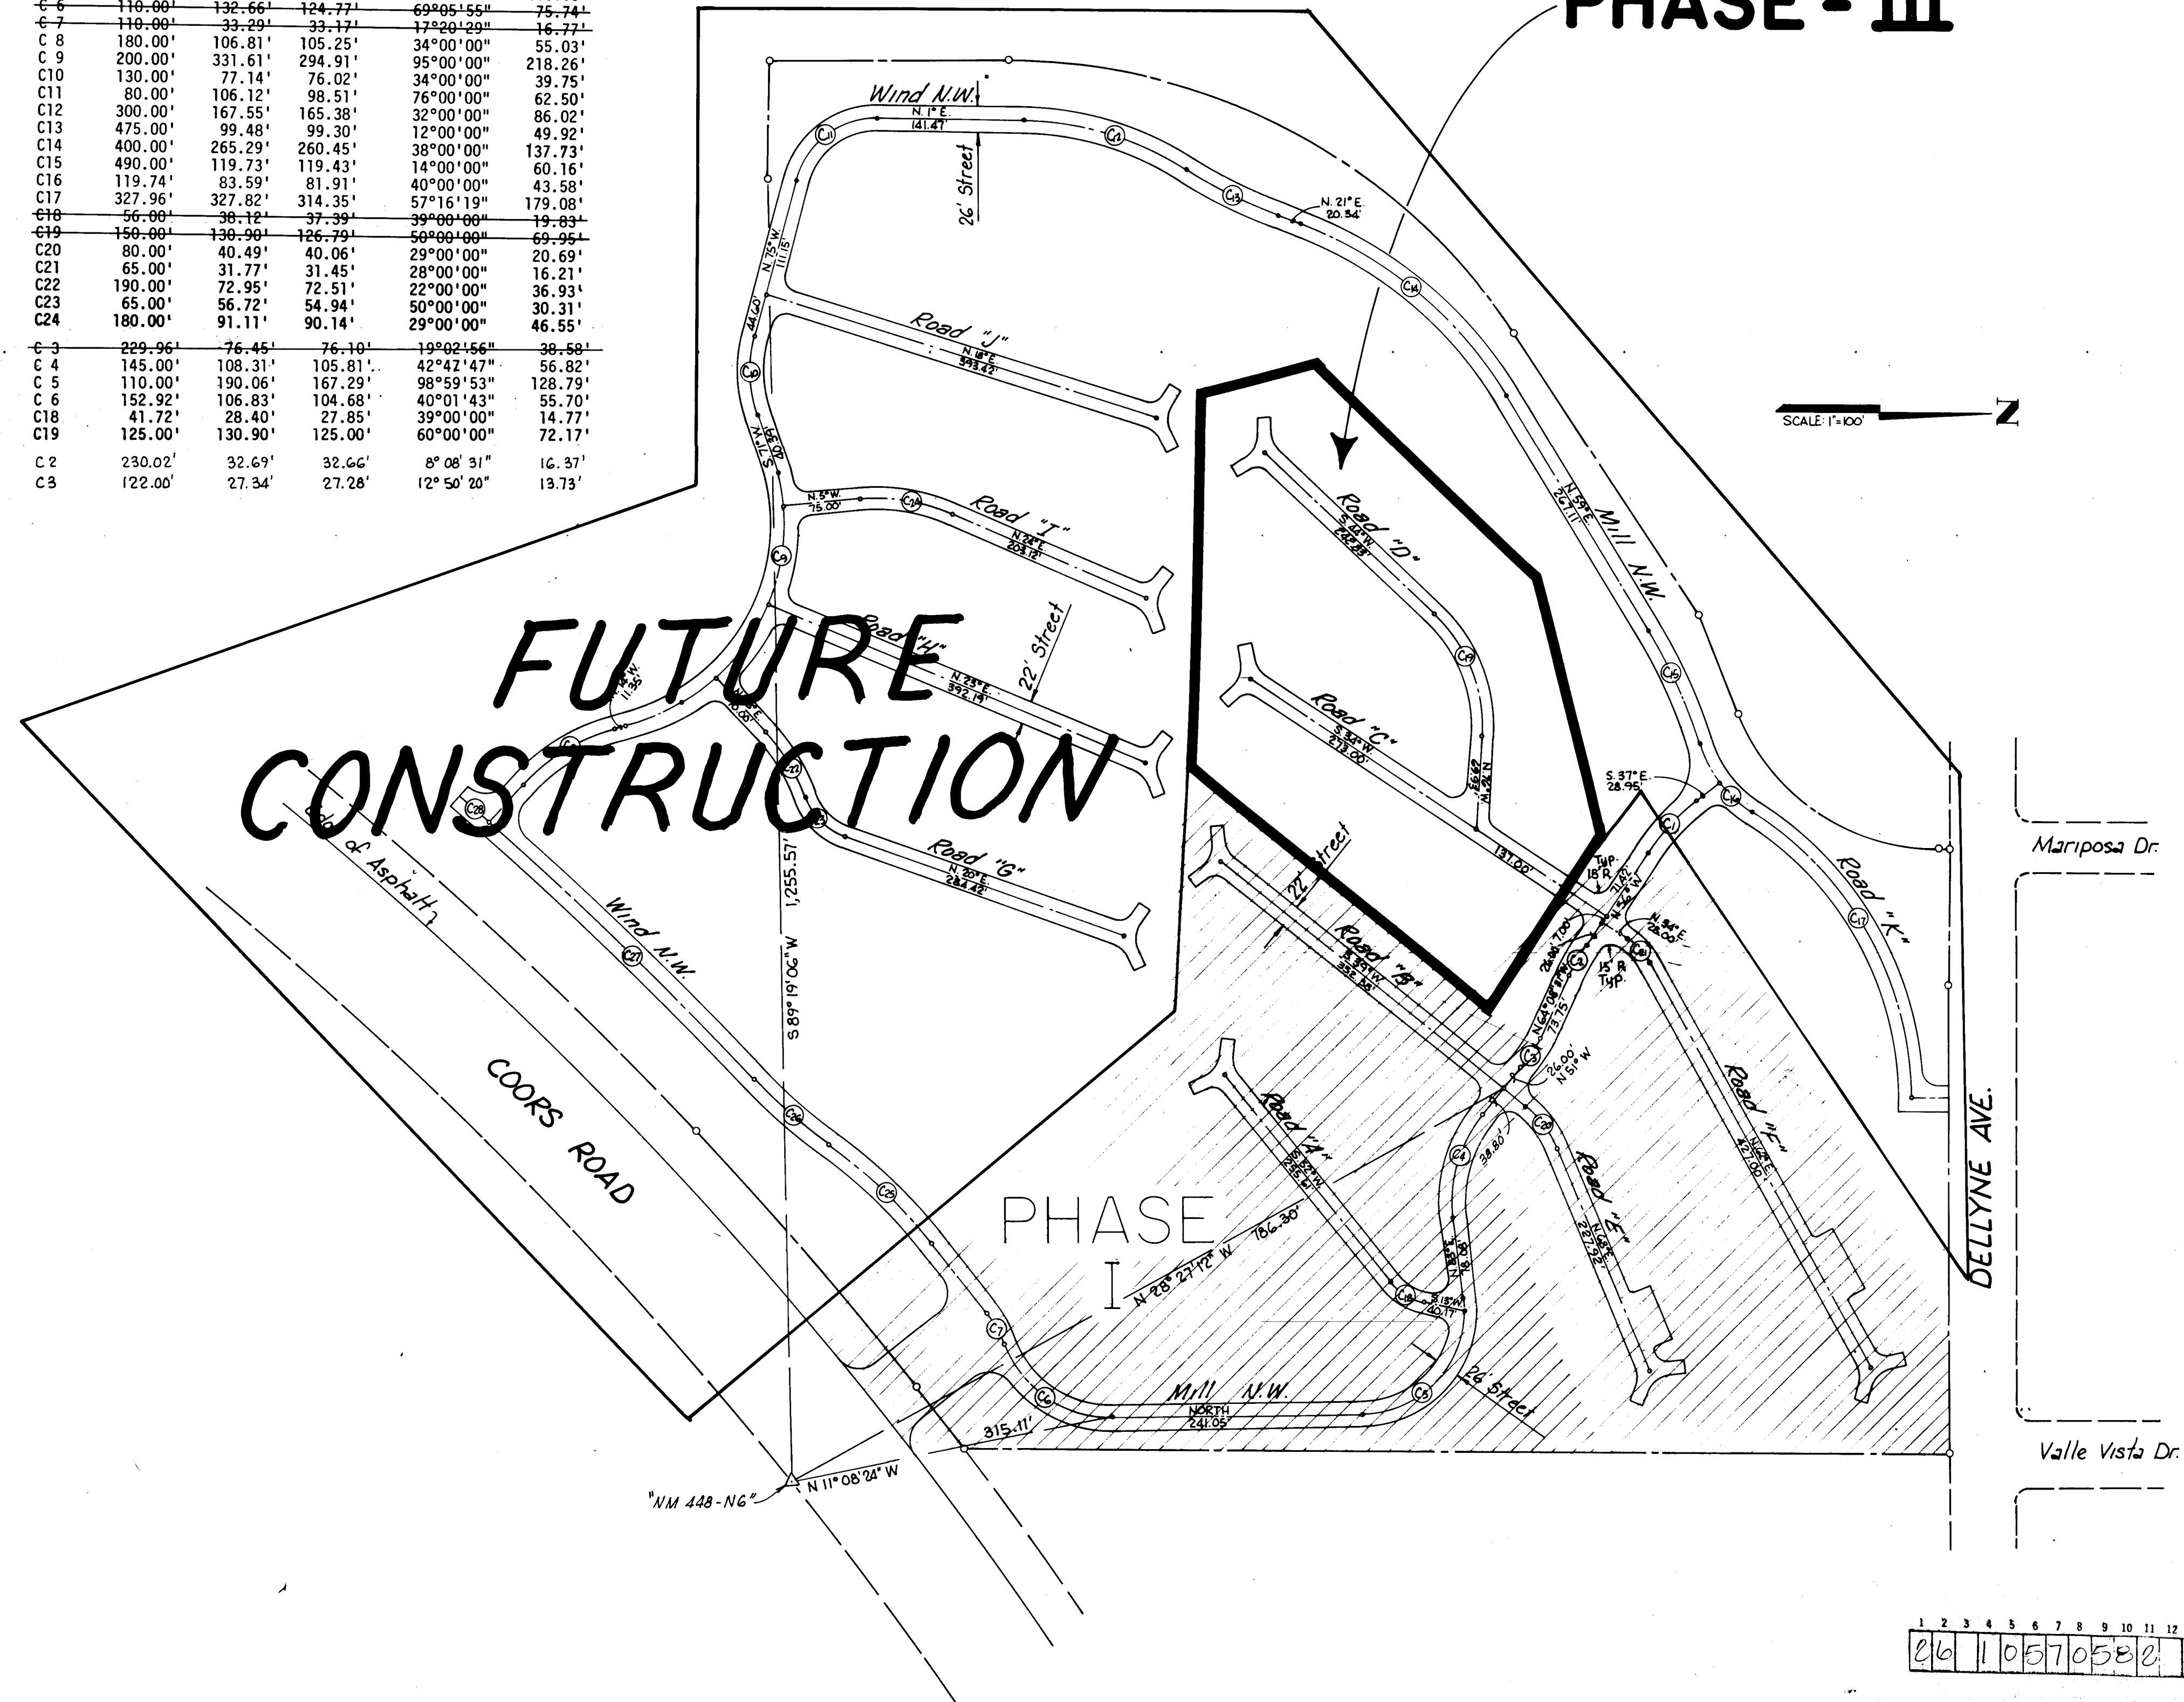

TYPICAL PARKING BAY
See sheet 1A for length & location

PHASE - III

PHASE I

SCALE 1"=100'

Mariposa Dr.

DELLYNE AVE.

Valle Vista Dr.

26 110570582


APPROVED FOR
CONSTRUCTION

CITY ENGINEER DATE


CITY OF ALBUQUERQUE PUBLIC WORKS DEPARTMENT ENGINEERING DIVISION					
TITLE: LA LUZ DEL OESTE UNIT 4 PAVING LAYOUT PHASE-III					
APPROVALS	ENGINEER	DATE	APPROVALS	ENGINEER	DATE
City Engineer			Liquid Waste	NA	10/1/80
A.C.E. Design			Traffic	NA	10/1/80
A.C.E. Hydrology			Water	NA	10/1/80
DRAWING NO. 1057			SHEET 5 OF 8		

AS-BUILT INFORMATION		BENCH MARKS		SURVEY INFORMATION		REFERENCES		REVISIONS	
CONTRACTOR	WORK	MAP NO.	ELEV. 5058.89	FIELD NOTES	BY	MAP NO.	W.O. NO.	NO. DATE	BY
ACCEPTED BY	DATE	NM 448-N6	Elev. 5058.89	DATE	NO.	EST. NO.			
CONTROLLED BY	DATE	NMSHC Brass tablet on the South side of State Road 448 (Coors Road N.W.) in the entrance of the La Luz Condominium.							
MICRO-FILM INFORMATION	RECORDED BY								
DATE									

DESIGNED BY: T.T. BURNETT ENGINEERING INC.
120 MORNINGSIDE DRIVE N.E. 07100
ALBUQUERQUE, N.M.

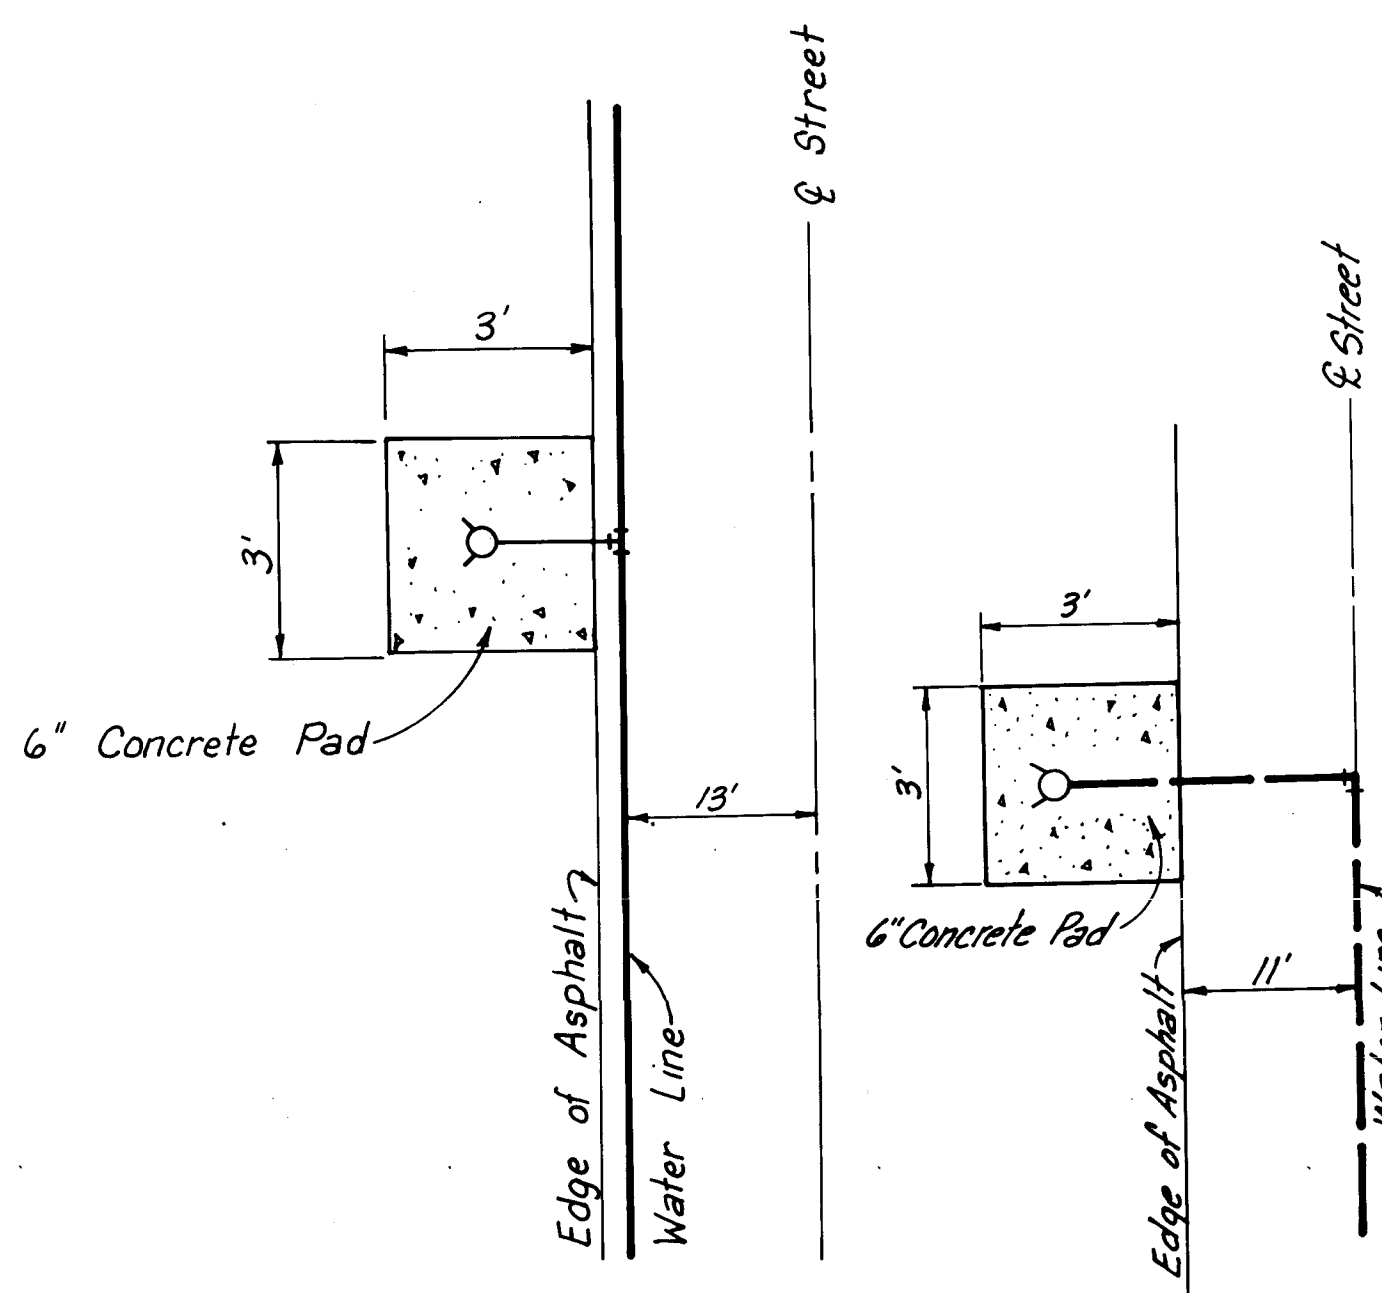


FIRE HYDRANT LOCATION

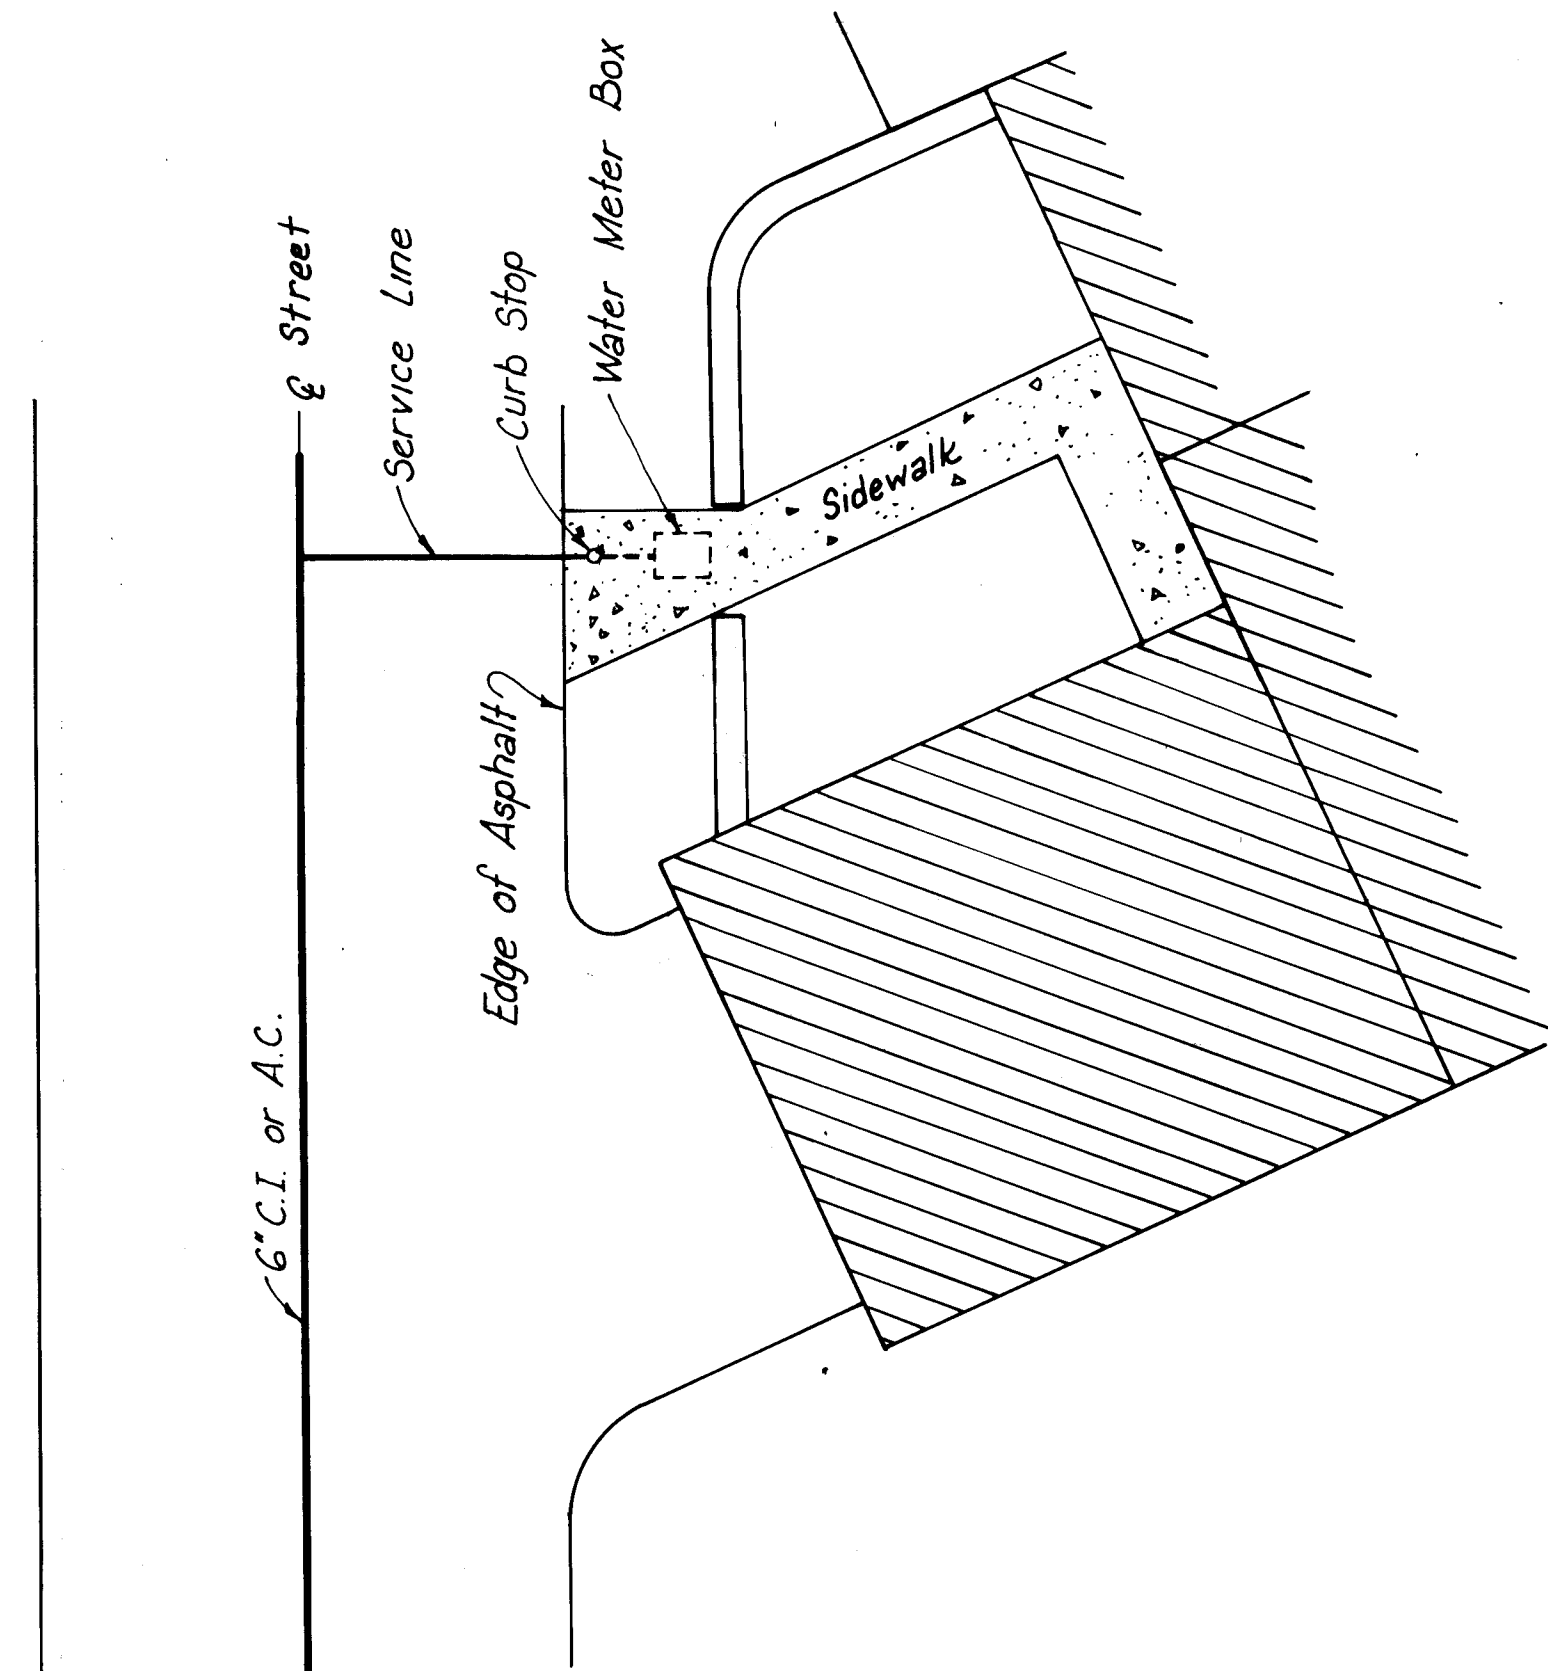

WATER METER BOX LOCATION

CITY OF ALBUQUERQUE
STANDARD WATER DETAILS

W-2
W-4
W-12
W-16
W-18
W-20
W-21

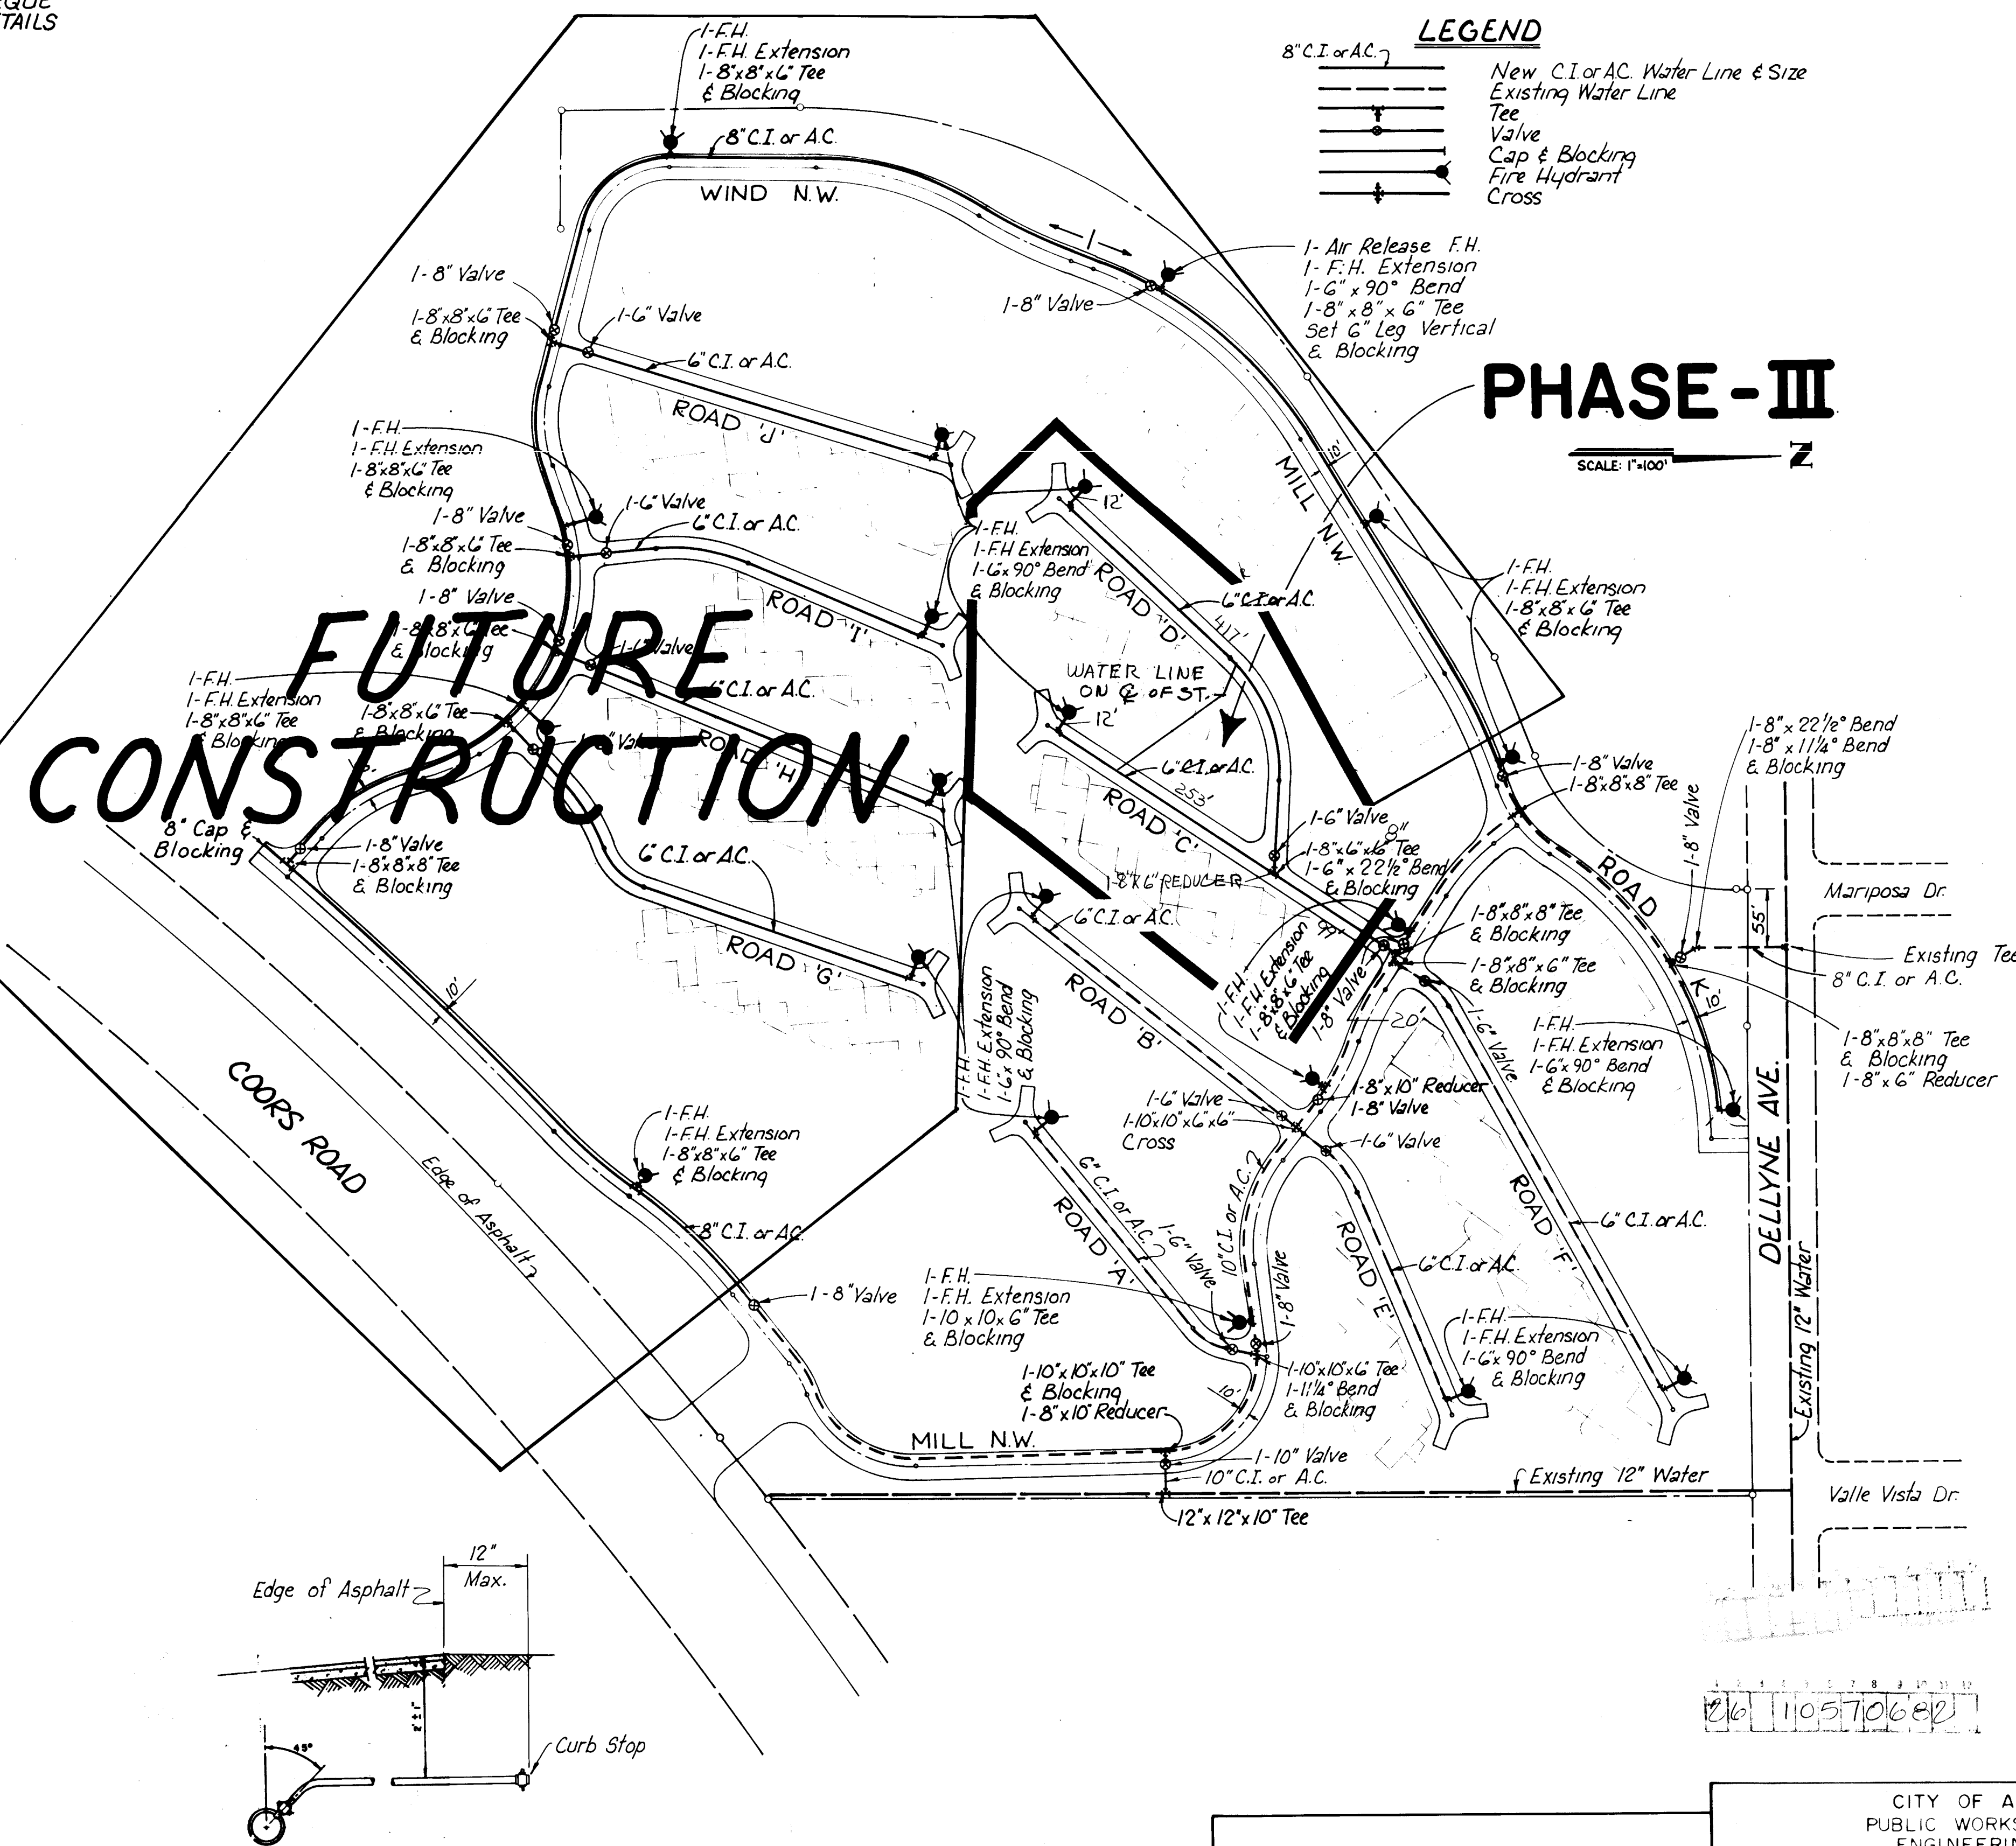

LEGEND

8" CI or AC
New CI or AC Water Line & Size
Existing Water Line
Valve
Cap & Blocking
Fire Hydrant
Cross

PHASE-III

SCALE 1"=100'


AS-BUILT INFORMATION		BENCH MARKS		SURVEY INFORMATION		REFERENCES		REVISIONS		REMARKS	
CONTRACTOR	DATE	NO.	DATE	NO.	DATE	NO.	DATE	NO.	DATE	NO.	DATE
WIND N.W.	Elev. 5058.87	NO. 448 N.W.	DATE	NO. 11	DATE	NO. 11	DATE	NO. 11	DATE	NO. 11	DATE
DESIGNED BY: T.T. BURNETT ENGINEERING INC. 120 MORNINGSTAR DRIVE, N.E. ALBUQUERQUE, N.M. 87105											

CITY OF ALBUQUERQUE
PUBLIC WORKS DEPARTMENT
ENGINEERING DIVISION


TITLE
**LA LUZ DEL OESTE UNIT 4
WATER LAYOUT PHASE-III**

APPROVALS	ENGINEER	DATE	APPROVALS	ENGINEER	DATE
City Engineer	ACE Design	ACE Hydrology	Liquid Waste	Traffic	Water

DRAWING NO. **1057** SHEET 6 OF 8

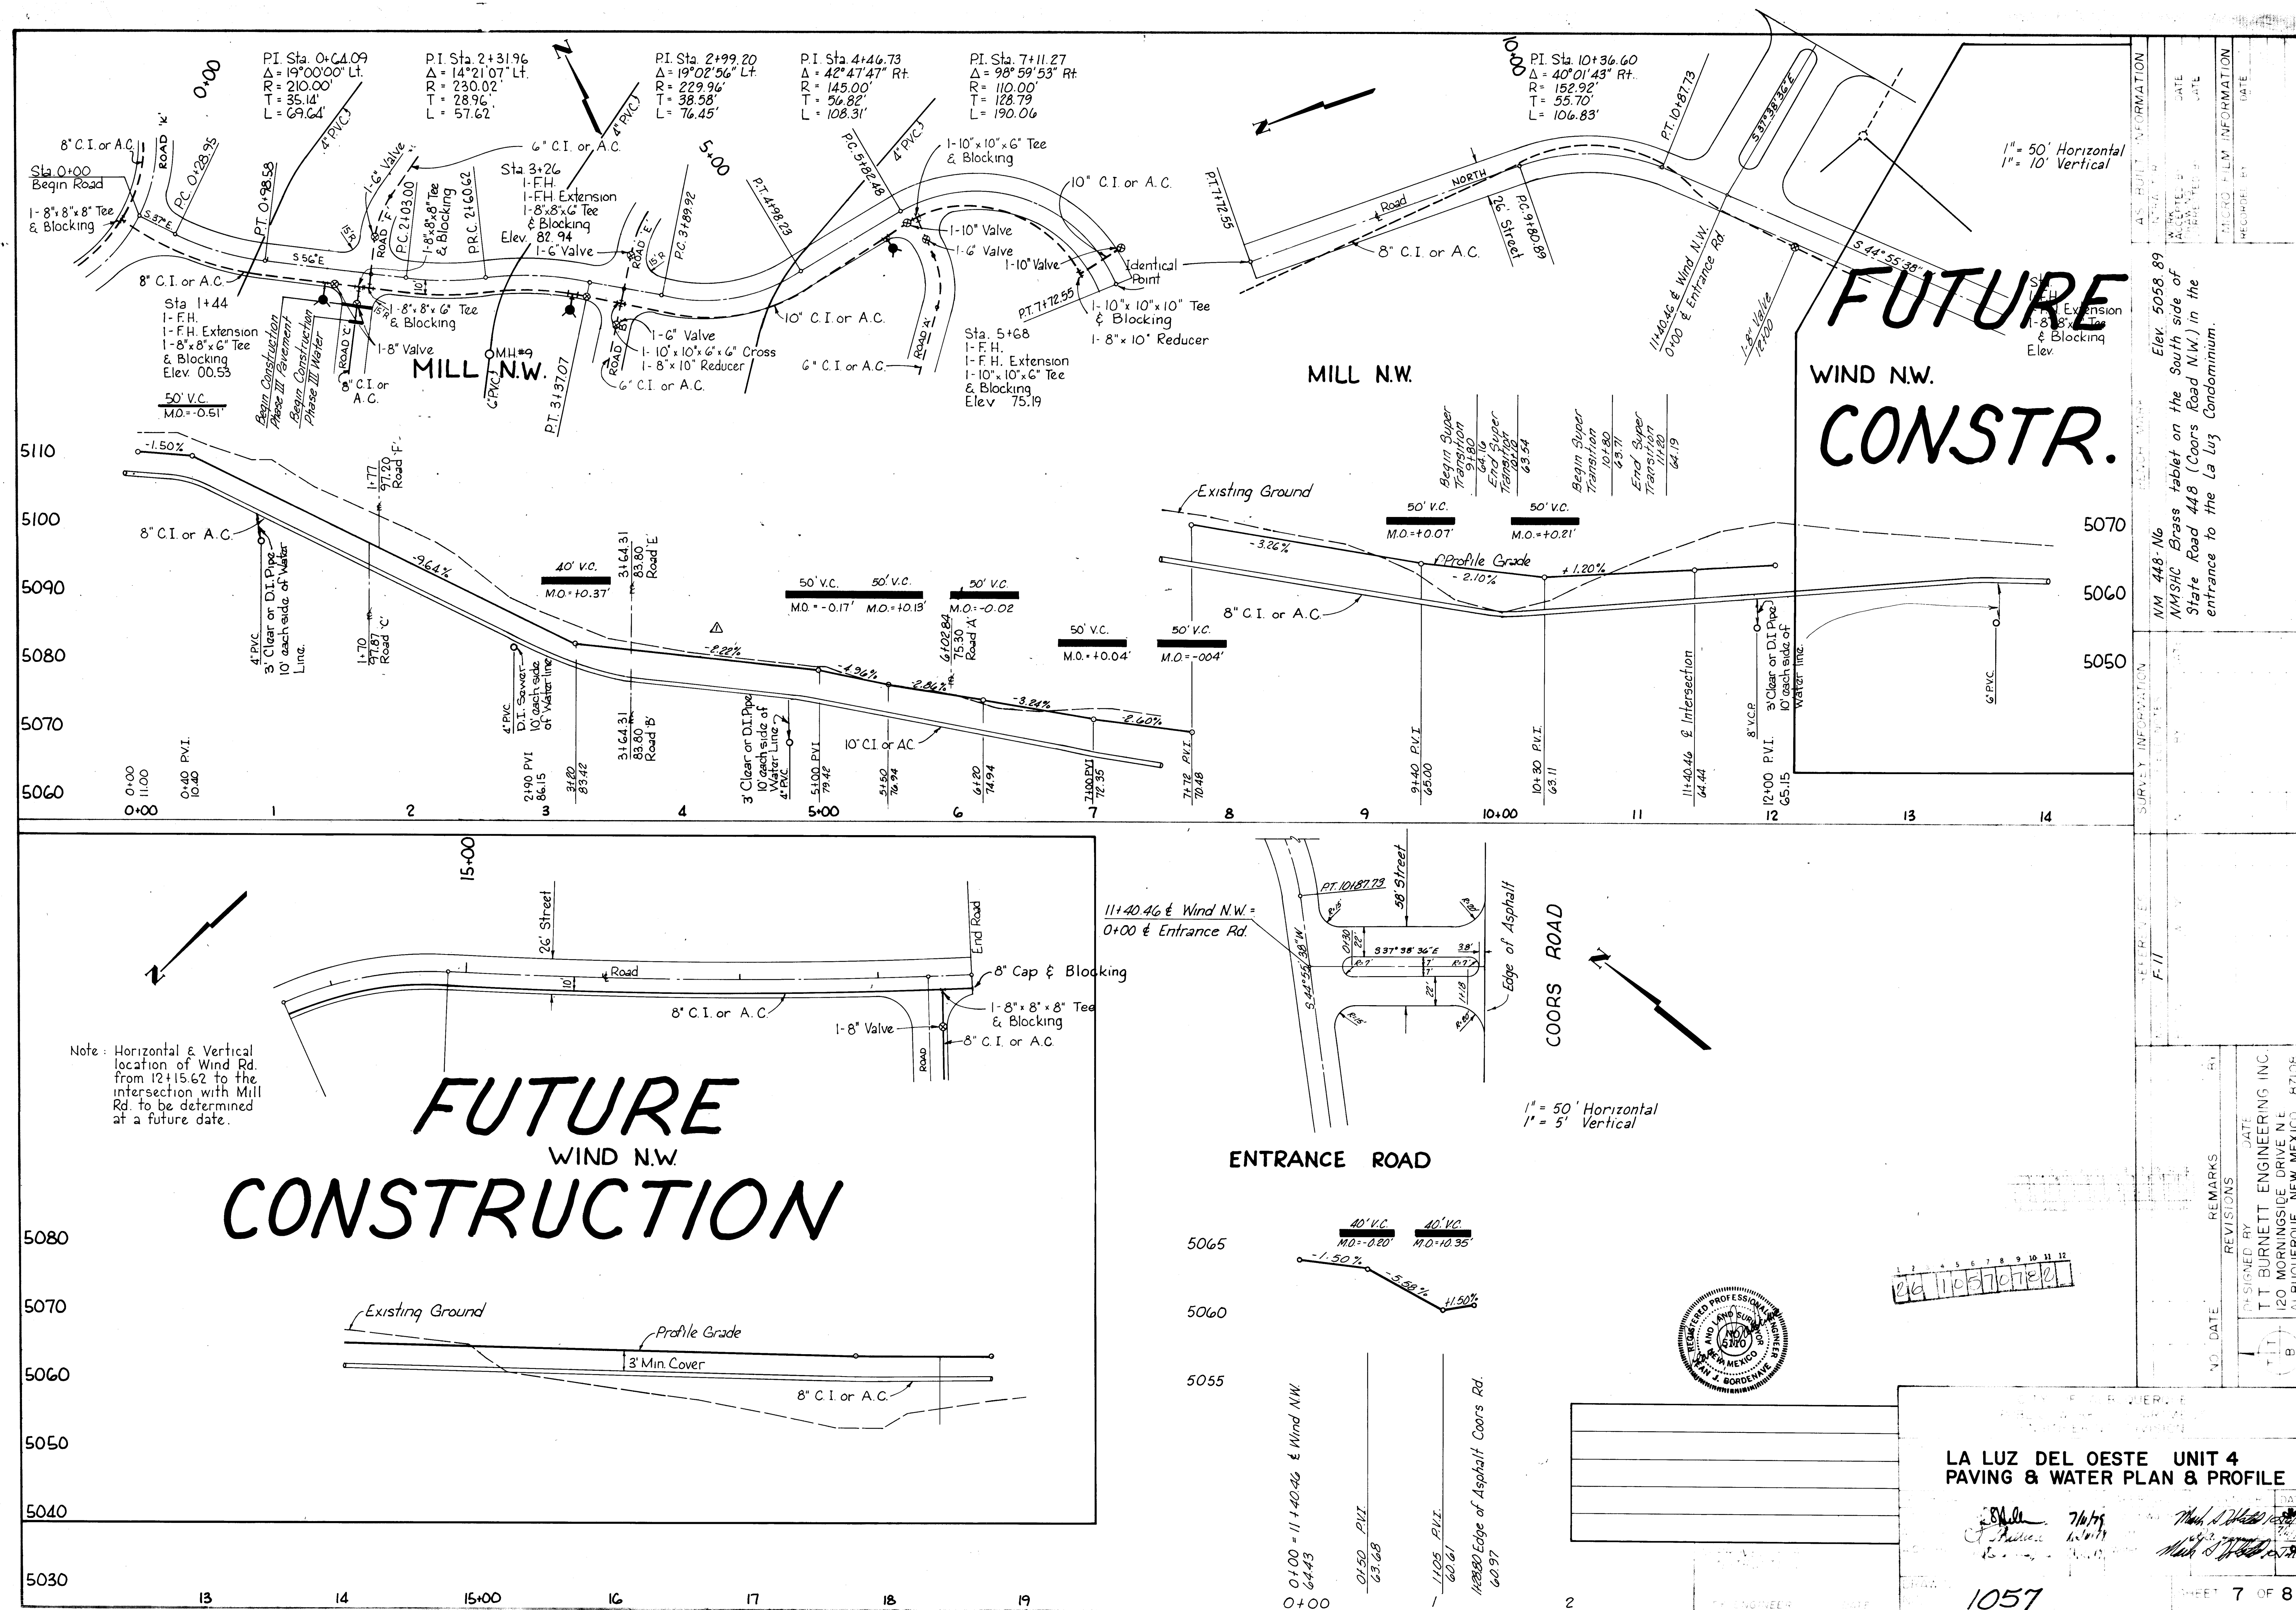

ORIGINAL	BY	DATE
SURVEYED		
PLOTTED		
INDEXED		
AREAS		
AREAS CHECKED		
NO		

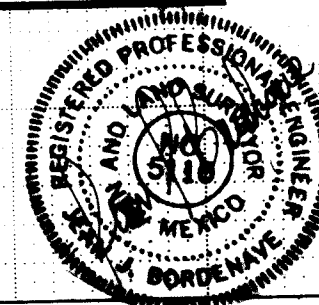

CITY ENGINEER DATE

CITY OF ALBUQUERQUE PUBLIC WORKS DEPARTMENT ENGINEERING DIVISION					
TITLE:					
APPROVALS	ENGINEER	DATE	APPROVALS	ENGINEER	DATE
City Engineer			Liquidation	10/24/29	
A.C.E. Design	French	11/27/29	Walt S. Hight	10/24/29	
A.C.E. Hydrology			R. Langrange	11/27/29	
DRAWING NO.			SHEET OF		

