


WYOMING SEWER LINE

15" REPLACEMENT LINE BETWEEN
KRIM & LOS ANGELES DR. N.E.

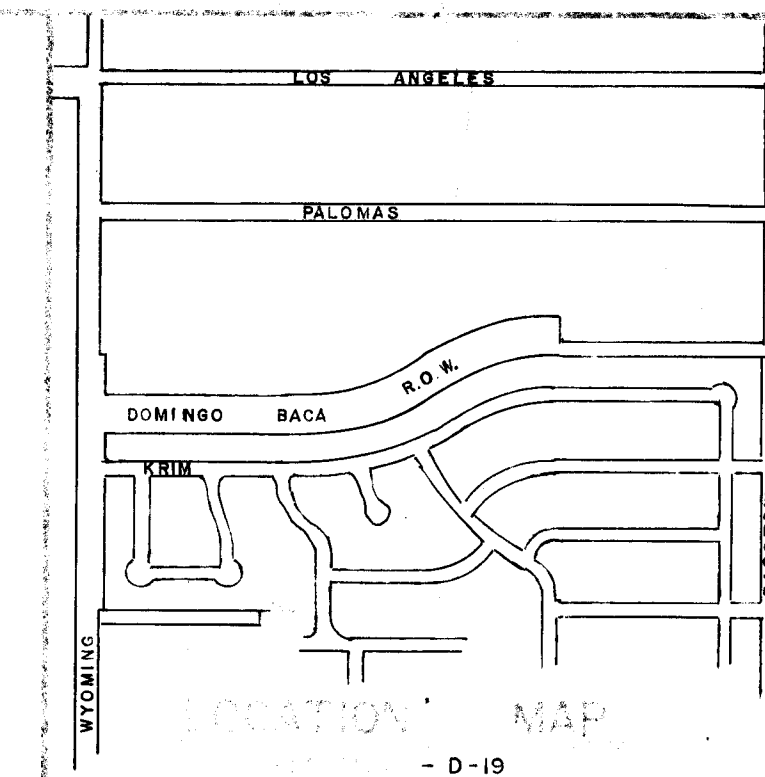

"NOTICE TO CONTRACTORS"

1. The owner (City of Los Angeles) has approved the design for the proposed sewer line replacement project. The design is based on the information provided by the contractor.
2. The contractor is responsible for obtaining all necessary permits and for obtaining the right of way for the project.
3. The contractor is responsible for the construction of the sewer line replacement project in accordance with the design and specifications.
4. The contractor is responsible for the construction of the sewer line replacement project in accordance with the design and specifications.
5. The contractor is responsible for the construction of the sewer line replacement project in accordance with the design and specifications.

"NOTICE TO CONTRACTORS"

1. The owner (City of Los Angeles) has approved the design for the proposed sewer line replacement project. The design is based on the information provided by the contractor.
2. The contractor is responsible for obtaining all necessary permits and for obtaining the right of way for the project.
3. The contractor is responsible for the construction of the sewer line replacement project in accordance with the design and specifications.
4. The contractor is responsible for the construction of the sewer line replacement project in accordance with the design and specifications.
5. The contractor is responsible for the construction of the sewer line replacement project in accordance with the design and specifications.

1 2 3 4 5 6 7 8 9 10 11 12
1 0 8 3 1 0 8 2


 
APPROVAL OF AS BUILT DRAWINGS
ASSISTANT CITY ENGINEER FIELD
DATE 1/10/02

REV. A APPROVED
FOR CONSTRUCTION
CITY ENGINEER
DATE 7/2/01



APPROVED FOR
CONSTRUCTION
DATE 7/2/01

1083

SHEET OF
1 3

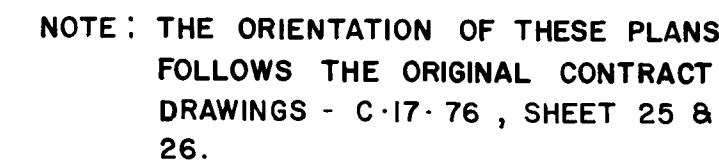

ESTIMATED QUANTITIES		
TYPE 'E' MH, 4'DIA.	6	EA.
15" SEWER LINE - V.G.P.	1402	L.F.
15" SEWER LINE - CONC. ENCASED	150	L.F.
TRENCHING - OVER 18' DEPTH	1552	L.F.
BY PASS PUMPING TIME		L.S.
WET CONNECTION	3	EA.

 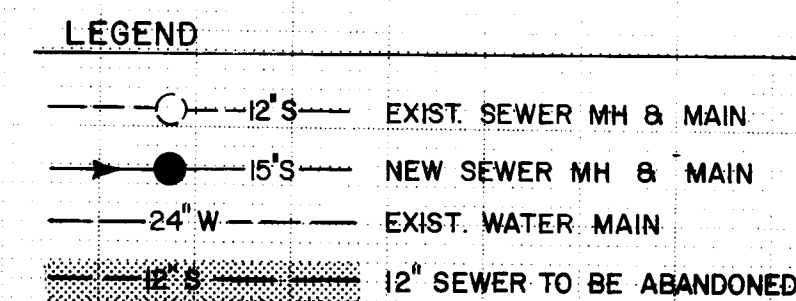

NOTE: EXISTING SEWER LINE FALLS DIRECTLY BEHIND
PROPOSED LINE ON PROFILE.

BENCH MARKS										SURVEY INFORMATION										AS BUILT INFORMATION									
TRIANGULATION OF STATION HEAVEN - 1969										FIELD NOTES										DATE									
ELEV. 5378.79										BY										DATE									
300' WEST OF 1/2 OF WYOMING BLVD.										NO										DATE									
82' SOUTH OF 1/2 OF LOS ANGELES DR.										NO										DATE									
MAP NO. D-19										EST NO.										W/O NO.									
CORRECTED CHANNEL BOTTOM ELEVATION										REMARKS										BY									
7/7/81										DATE										NO									
DESIGNED BY										D.E.C.										DATE									
DRAWN BY										D.E.C.										DATE									
CHECKED BY										D.E.C.										DATE									
REVISIONS										DESIGN										DATE									
3-81										3-81										3-81									
3-81										3-81										3-81									

ENGINEER

DATE

5-7-81

ON WYOMING BLVD.

DR. (15+27.70)



SHEET

2

OF

3

100

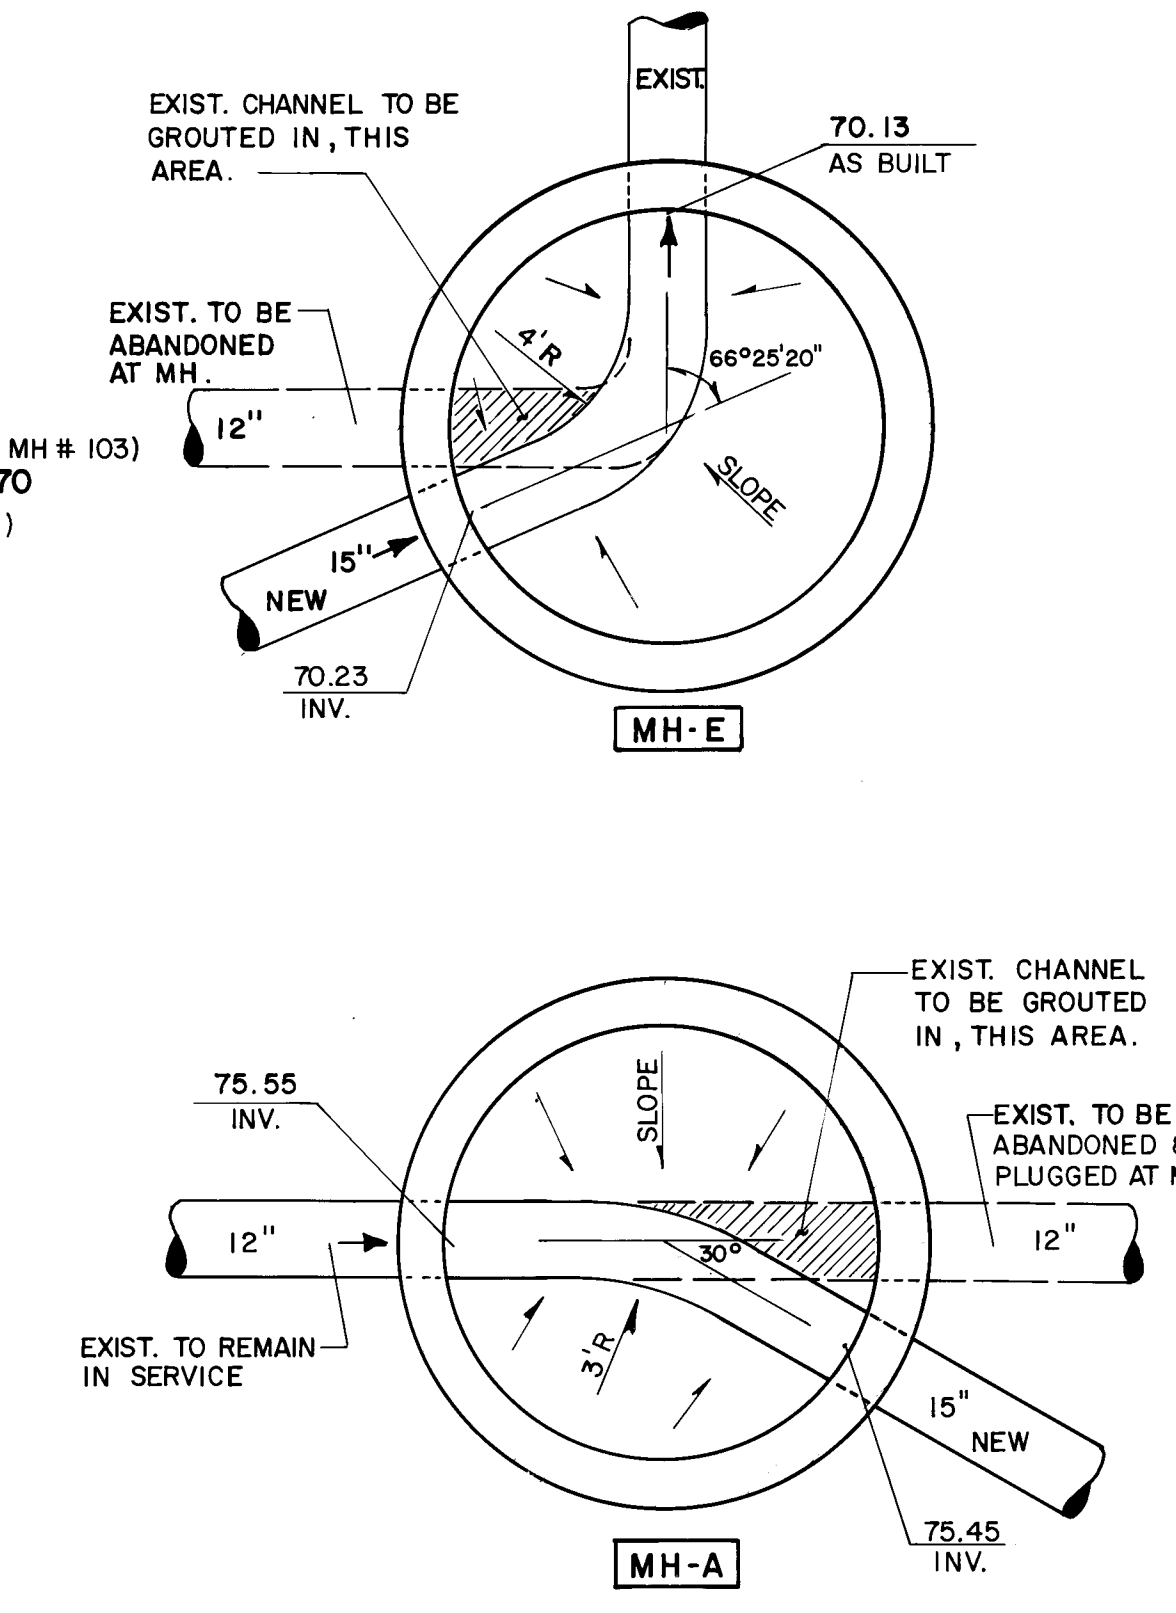
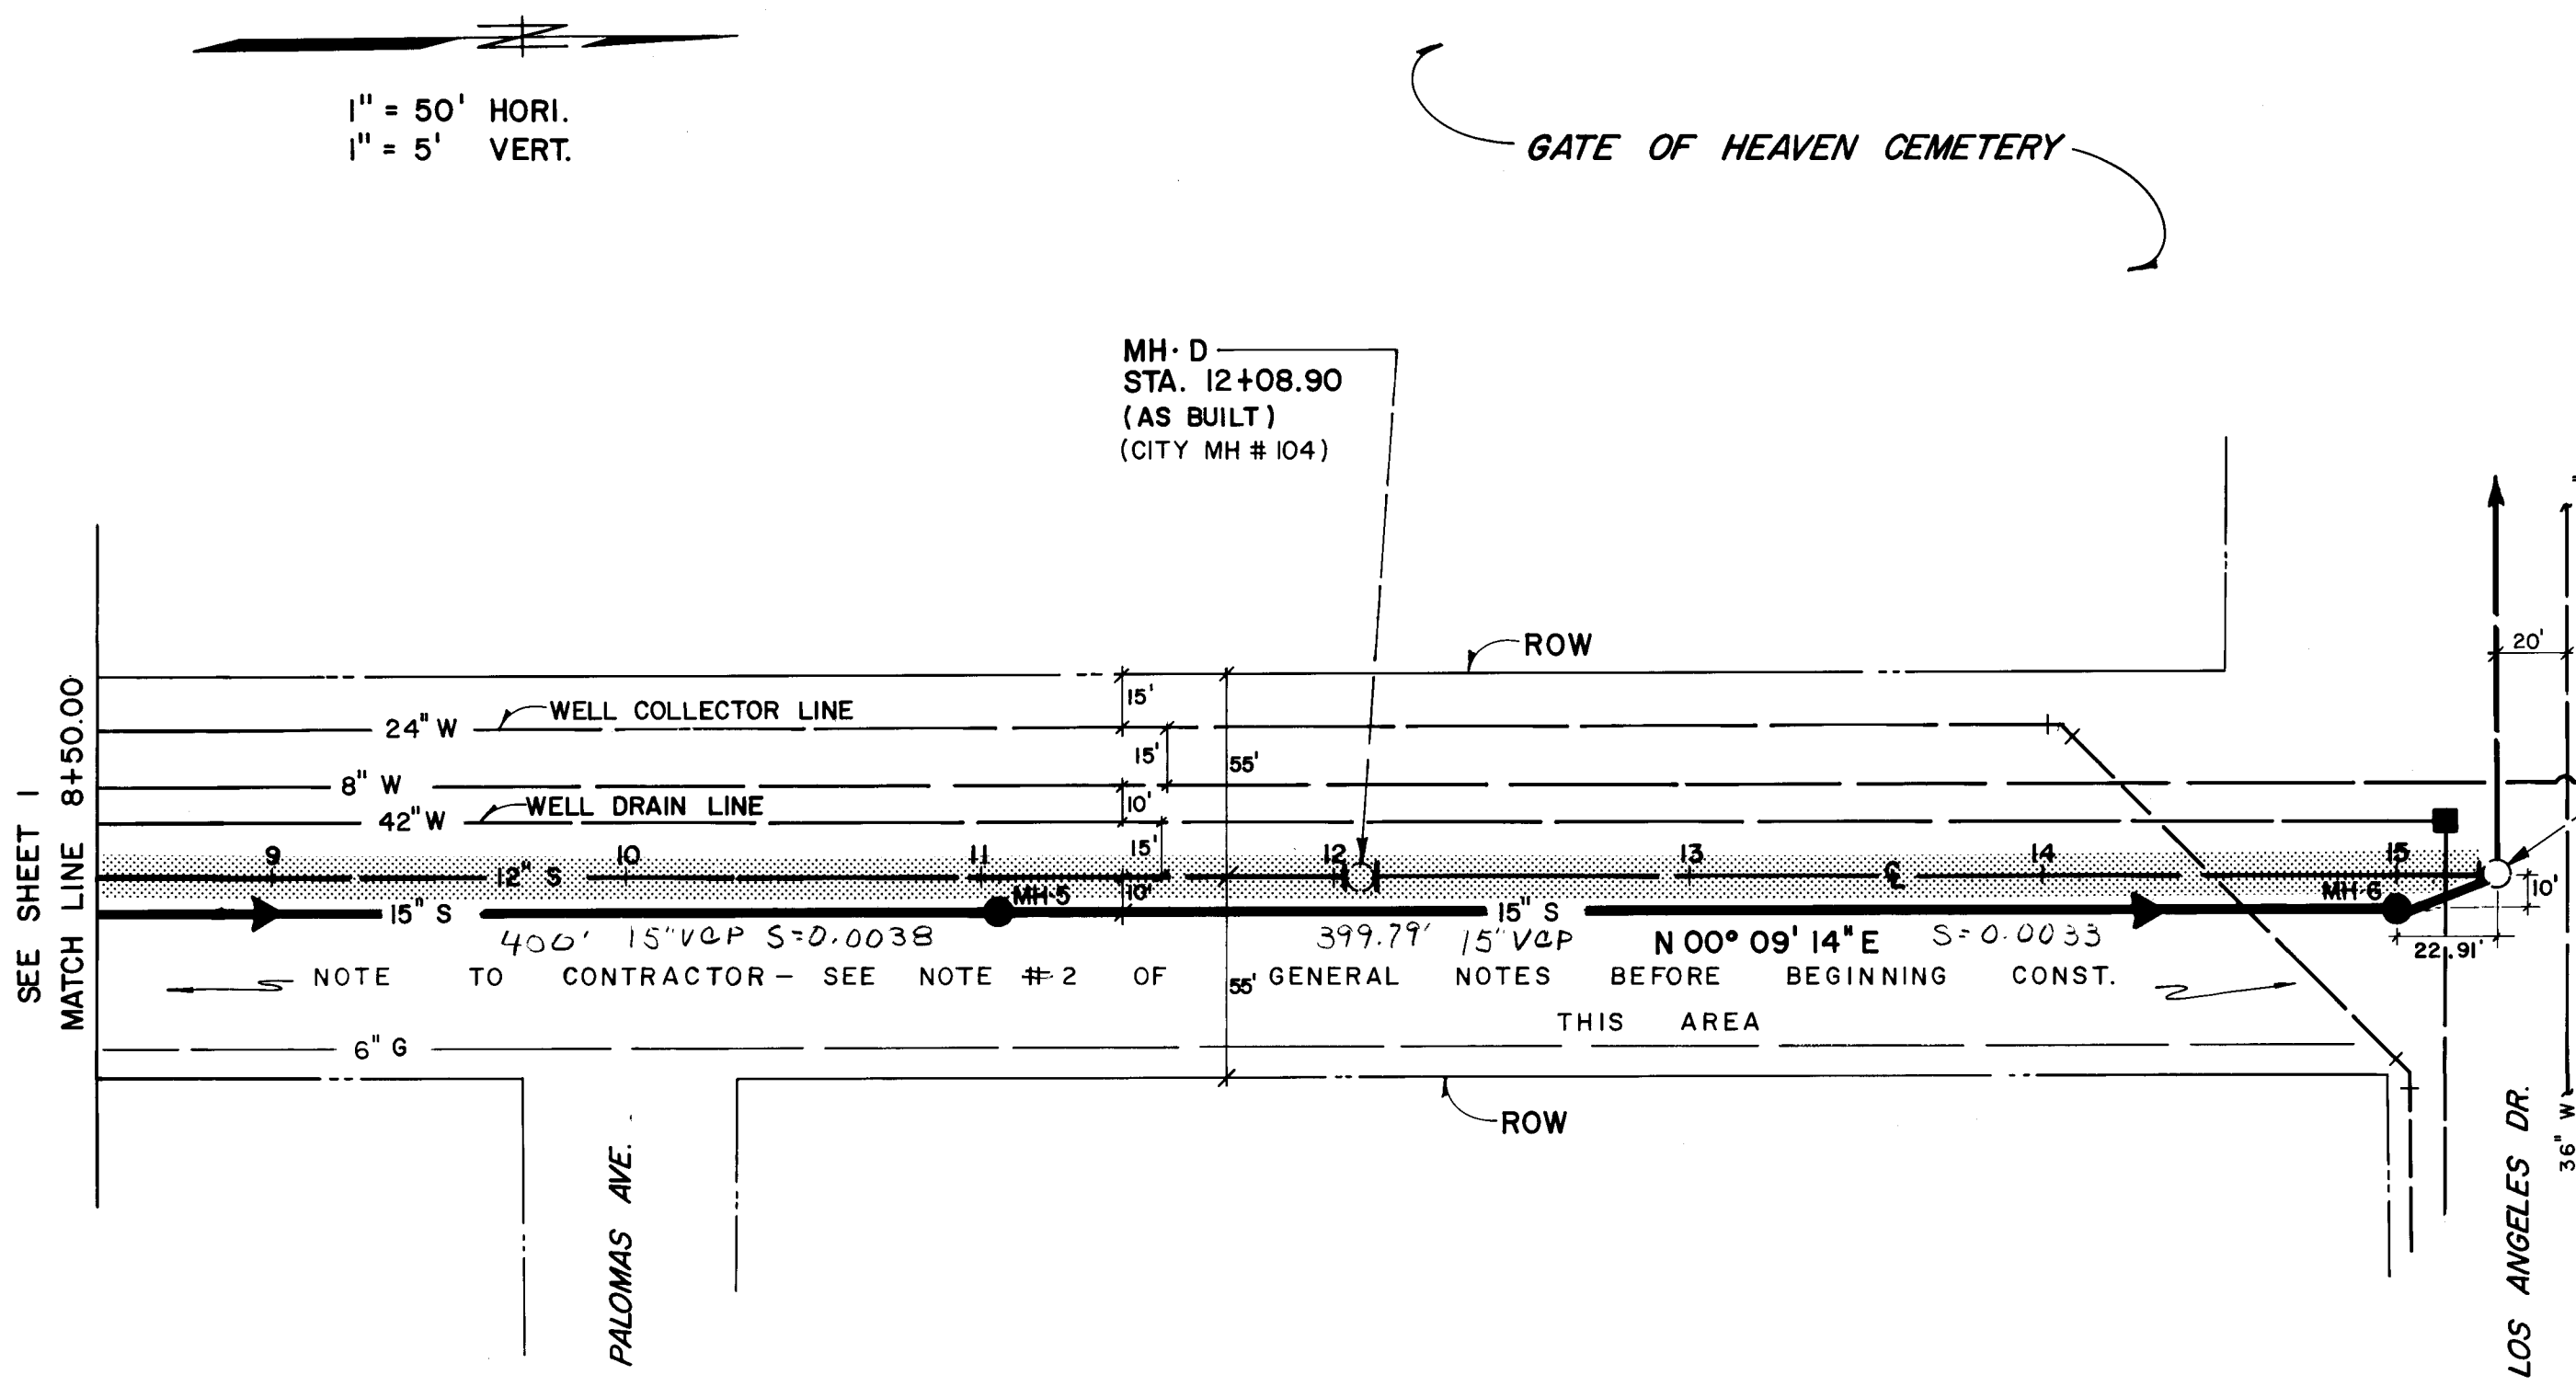


NOTICE TO CONTRACTORS

1. New Mexico Standard Specifications for Public Works Construction - 1979 Edition will be referred to hereon as the "Standard Specification".

2. All work detailed on these plans to be performed under contract shall, except as otherwise stated or provided for hereon, be constructed in accordance with "Contract Documents for City-Wide Utilities and Cash Paving No. 30" and the Standard Specification".

- GENERAL NOTES**
- Backfill compaction shall be according to specified street use. (Arterial)
 - Two working days prior to any excavation, contractor must contact Line Locating Service, 765-1234, for location of existing utilities.
 - Prior to construction, the contractor shall excavate and verify the horizontal and vertical locations of all obstructions. Should a conflict exist, the contractor shall notify the engineer or surveyor so that the conflict can be resolved with a minimum amount of delay.
 - This contract consists of constructing a new sewer line without interrupting flows; connecting existing MH-A to new MH-2; constructing new sewer line between MH-1, MH-2, MH-3, MH-4, MH-5 and MH-6; connecting new MH-6 to existing MH-E; constructing new MH-1 over existing 12" S.
 - After completion, inspection and acceptance of the proposed 15" sanitary sewer line the 12" lines between manhole No. 1, manhole A and manhole E shall be abandoned. The contractor shall place a 12" long mortared plug at locations indicated on the plans. The manholes to be abandoned shall then be filled with sand, the castings removed and returned to the Water Resources Department.
 - To put new line/manholes in service, divert flows of MH-1 to MH-2, plug line between MH-1 and MH-A; divert flows of MH-A to MH-2, plug line north of MH-A; plug south invert of 12" existing line into MH-E.
 - Contractor to coordinate traffic control on Wyoming Blvd. with City Traffic Department prior to beginning construction.
 - All MH's shall be Type "E", 4' inside diameter.

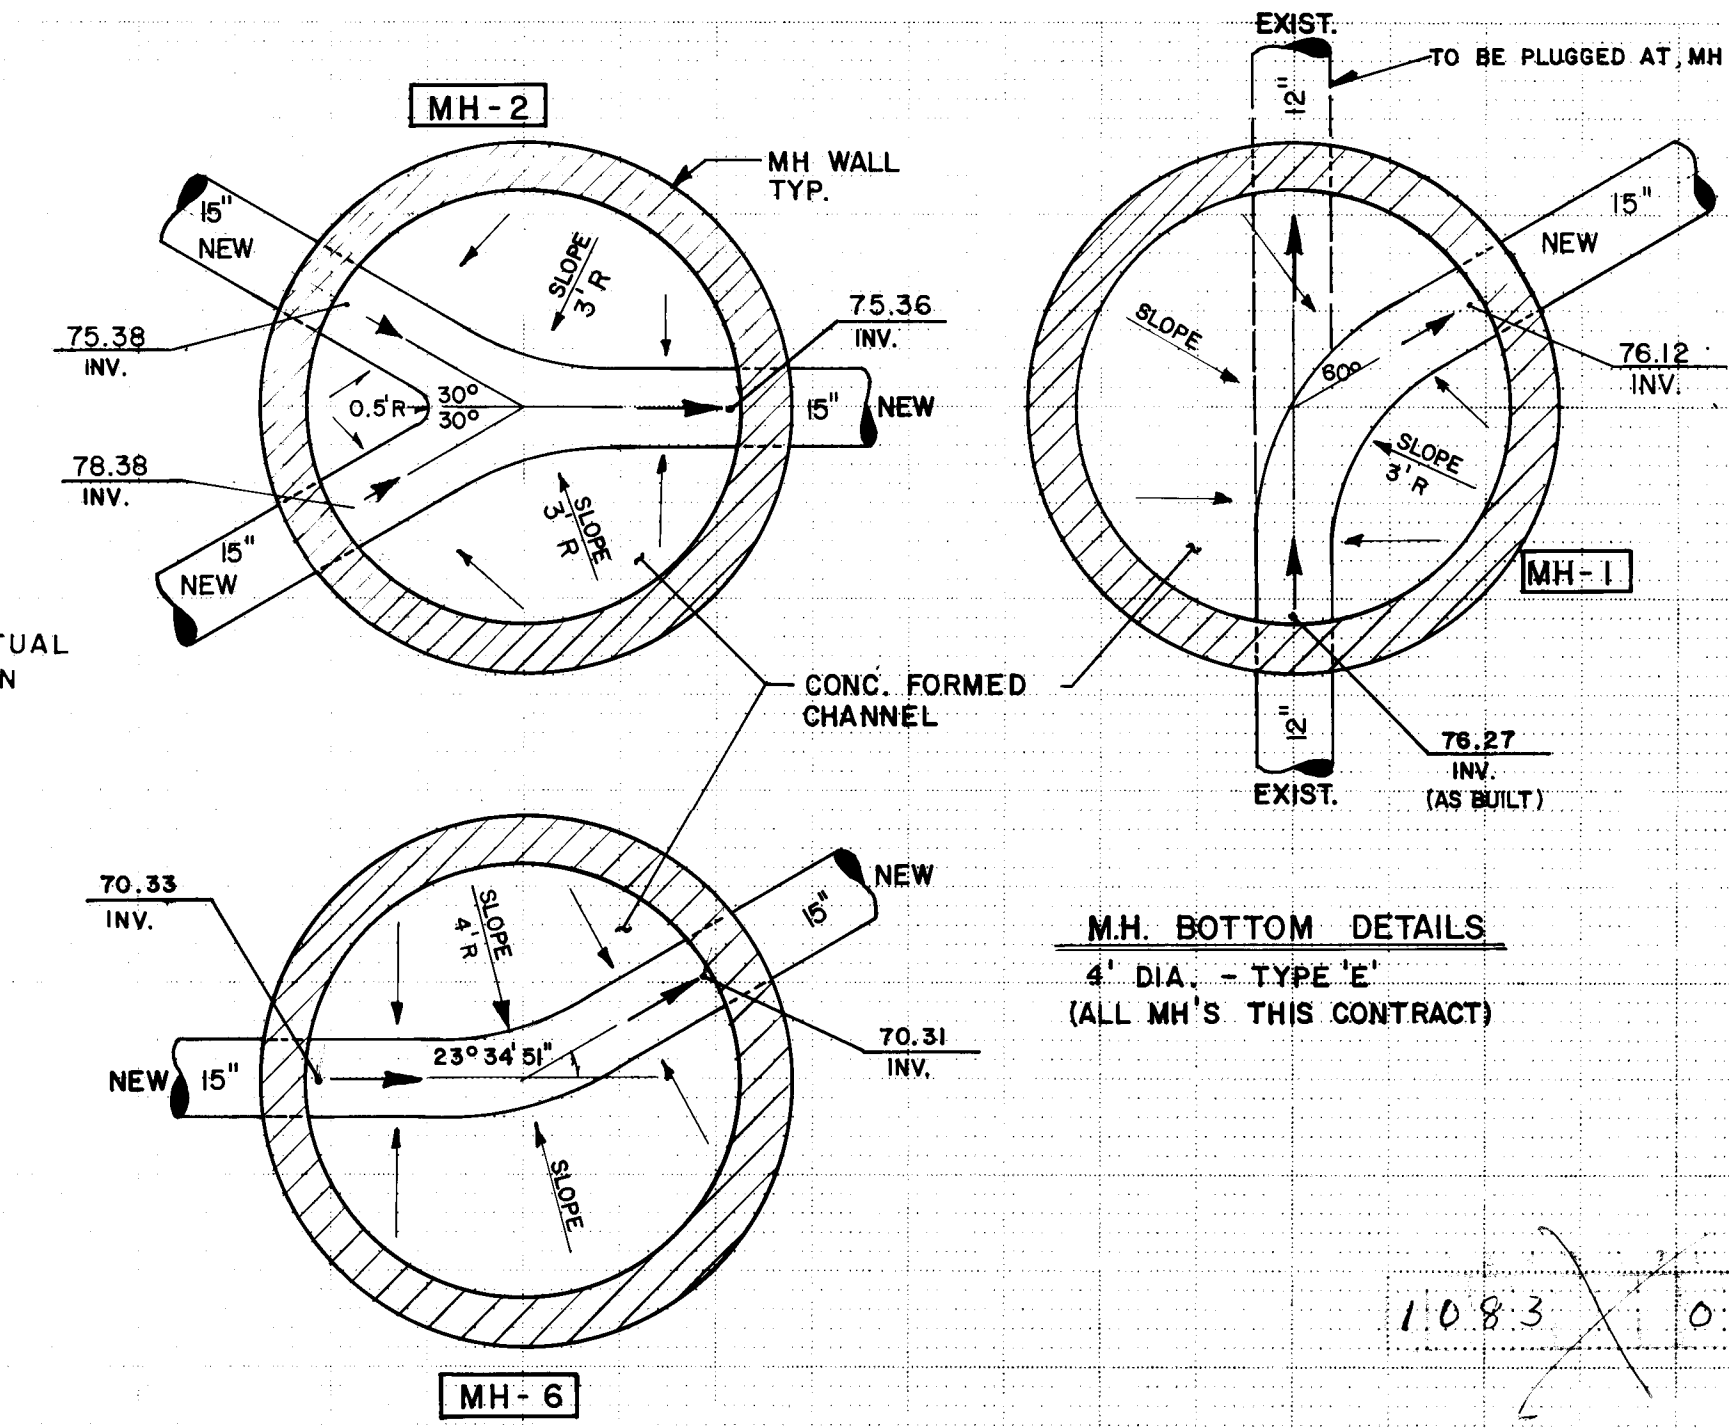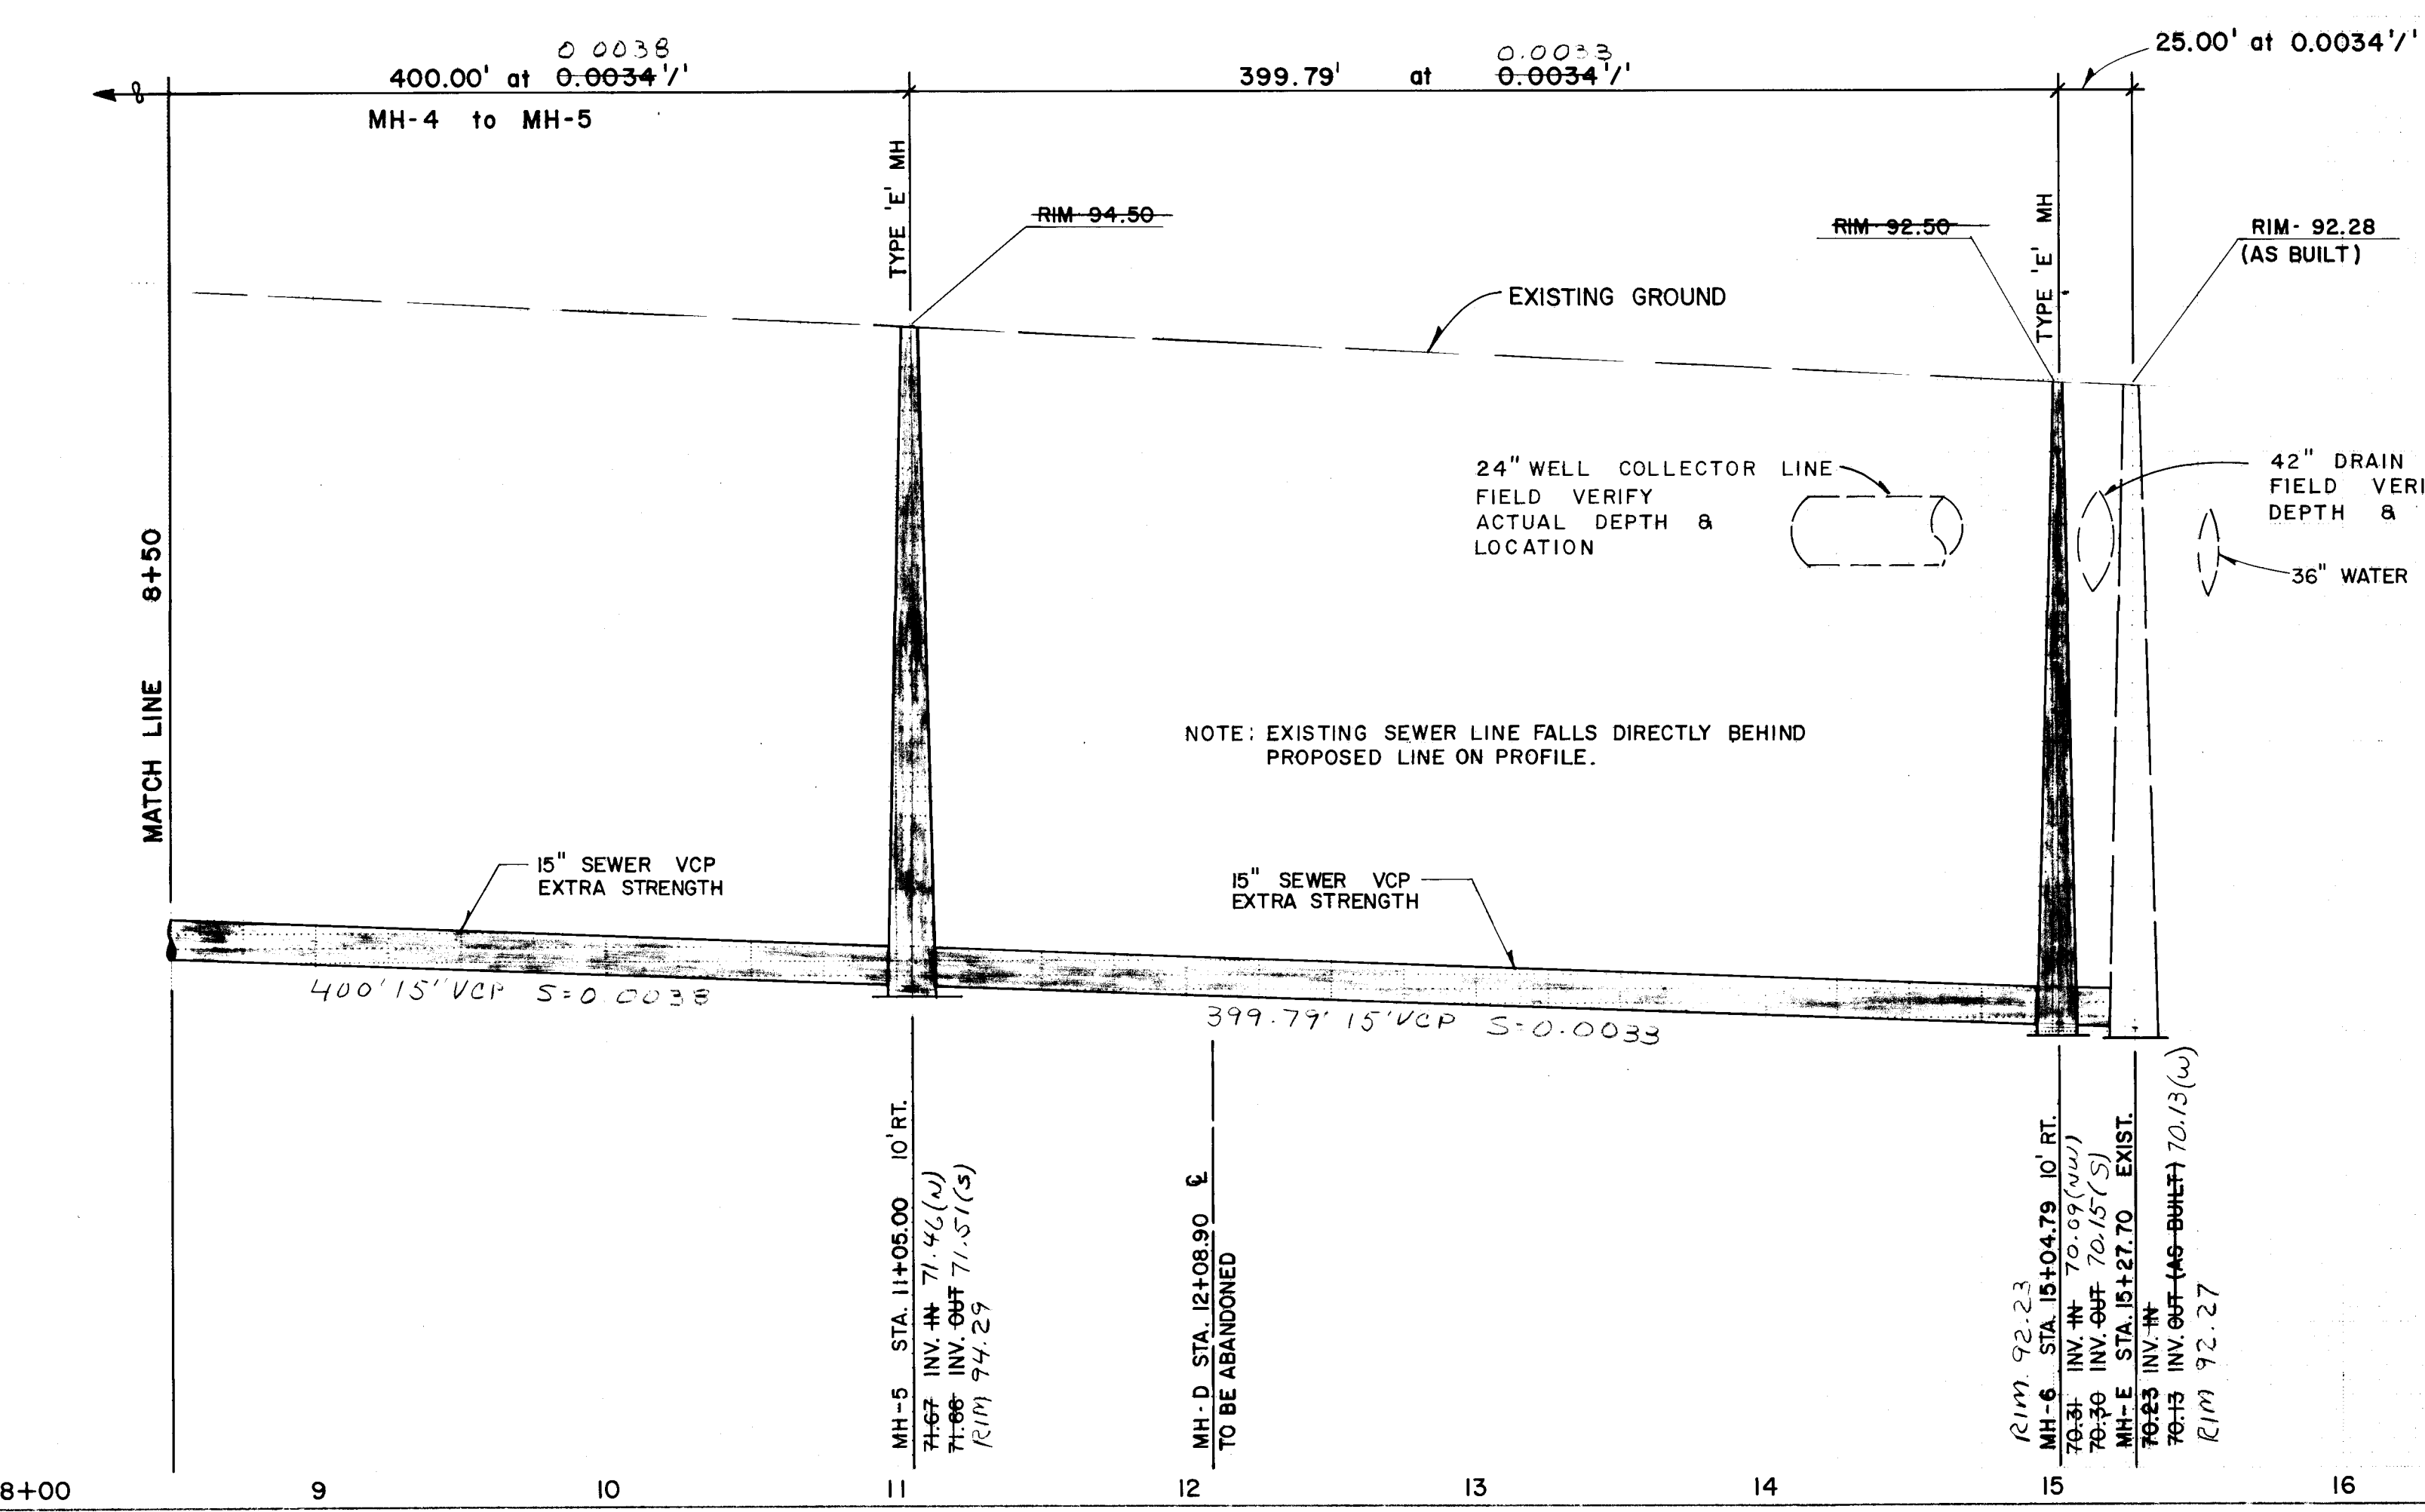

M.H. BOTTOM DETAILS
4' DIA. - TYPE "E"
(ALL MH'S THIS CONTRACT)

1083 0382

APPROVED FOR CONSTRUCTION
CITY ENGINEER
DATE

CITY OF ALBUQUERQUE MUNICIPAL DEVELOPMENT ENGINEERING DIVISION					
TITLE: UTILITY PLAN & PROFILE					
15" SEWER REPLACEMENT LINE ON WYOMING BLVD. FROM KRIM DR. (0+00) TO LOS ANGELES DR. (15+27.70)					
APPROVALS	ENGINEER	DATE	APPROVALS	ENGINEER	DATE
City Engineer	<i>[Signature]</i>	5/1/81	Liquid Waste	<i>[Signature]</i>	5-7-81
A.C.E. Design	<i>[Signature]</i>	8/1/81	Traffic		
A.C.E. Hydrology			Water	N.A.	

DESIGN		
DESIGNED BY	DATE	3-81
DRAWN BY	DATE	3-81
CHECKED BY	DATE	3-81

NO. 1083 SHEET 3 OF 3