


BURLISON DRIVE
IMPROVEMENTS
BEAR CANYON VILLAGE

(MASTER WATER LINE)

INDEX	
SHEET NO.	TITLE
1	COVER SHEET
2	WATER PLAN & PROFILE

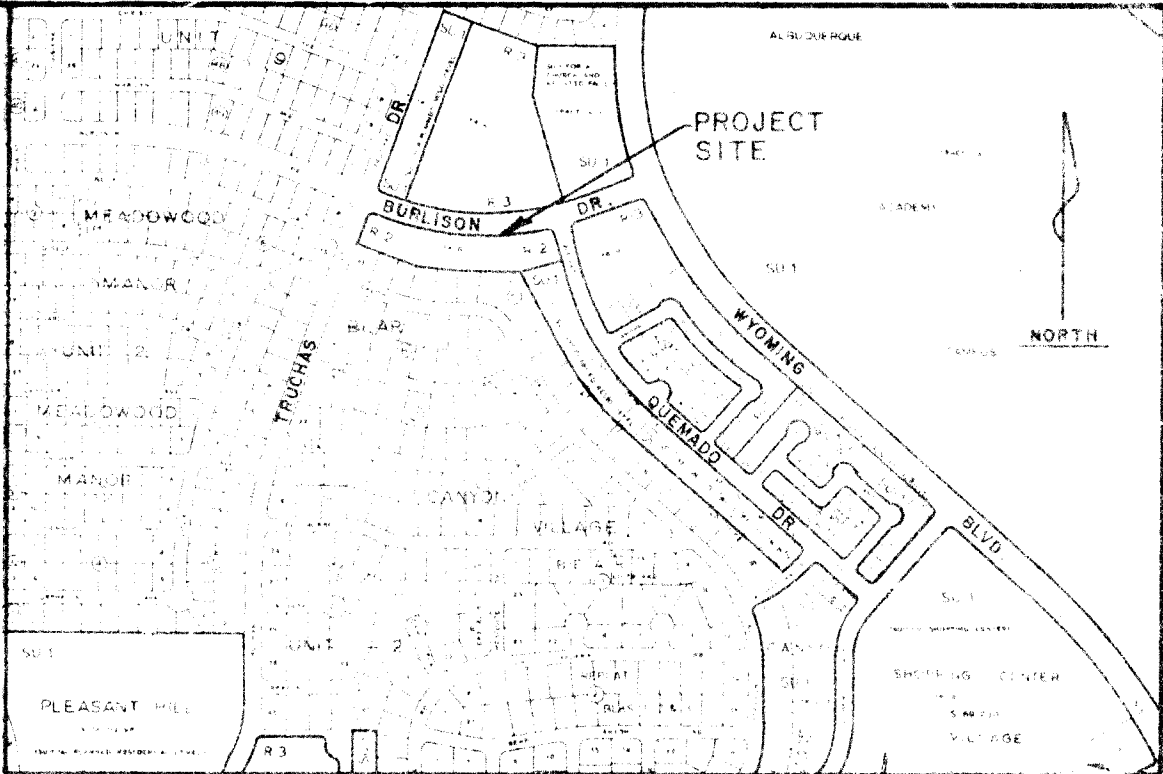

LOCATION MAP
ZONE ATLAS NO. E-19

"NOTICE TO CONTRACTOR"

- All work detailed on these plans to be performed under contract shall, except as otherwise stated or provided for herein, be constructed in accordance with the New Mexico Standard Specifications for Public Works Construction-1979 Edition (referred to herein as the Standard Specifications) and the Contract Documents for City-Wide Utilities and Gas Paving N. 31.
- Two (2) working days prior to any excavation, contractor must contact Line Locating Service, 265-1234, for location of existing utilities.
- Prior to construction, the contractor shall excavate and verify the horizontal and vertical locations of all obstructions. Should a conflict exist, the contractor shall notify the engineer or surveyor so that the conflict can be resolved with minimum amount of delay.

THE FOLLOWING NOTES APPLY WHEN CHECKED

- ☒ All utilities and utility service lines shall be installed prior to paving.
- ☒ Backfill compaction shall be according to specified street use.
- ☒ Tack coat requirements shall be determined by the City Engineer.
- ☐ Sidewalks and wheelchair ramps within the curb returns shall be constructed whenever a new curb return is constructed.
- ☐ If curb is depressed for a driveway or a handicap ramp, the driveway or ramp shall be constructed prior to acceptance of the curb and gutter.
- ☐ All storm drainage facilities shall be completed prior to final acceptance.

APPROVAL OF AS BUILT DRAWINGS
ASST. CITY ENGINEER - FIELD
<i>[Signature]</i>
DATE 8-13-83


26 1706 0103

REV	2									
SHEETS	2									
CITY ENGR.										
DATE										
USER DEPT.										
DATE										
USER DEPT.										
DATE										

APPROVAL OF REVISIONS

<i>[Signature]</i>	CITY OF ALBUQUERQUE	APPROVED FOR CONSTRUCTION
		<i>[Signature]</i> CITY ENGR.
1706	SHEET 1 OF 2	

AF 22440B

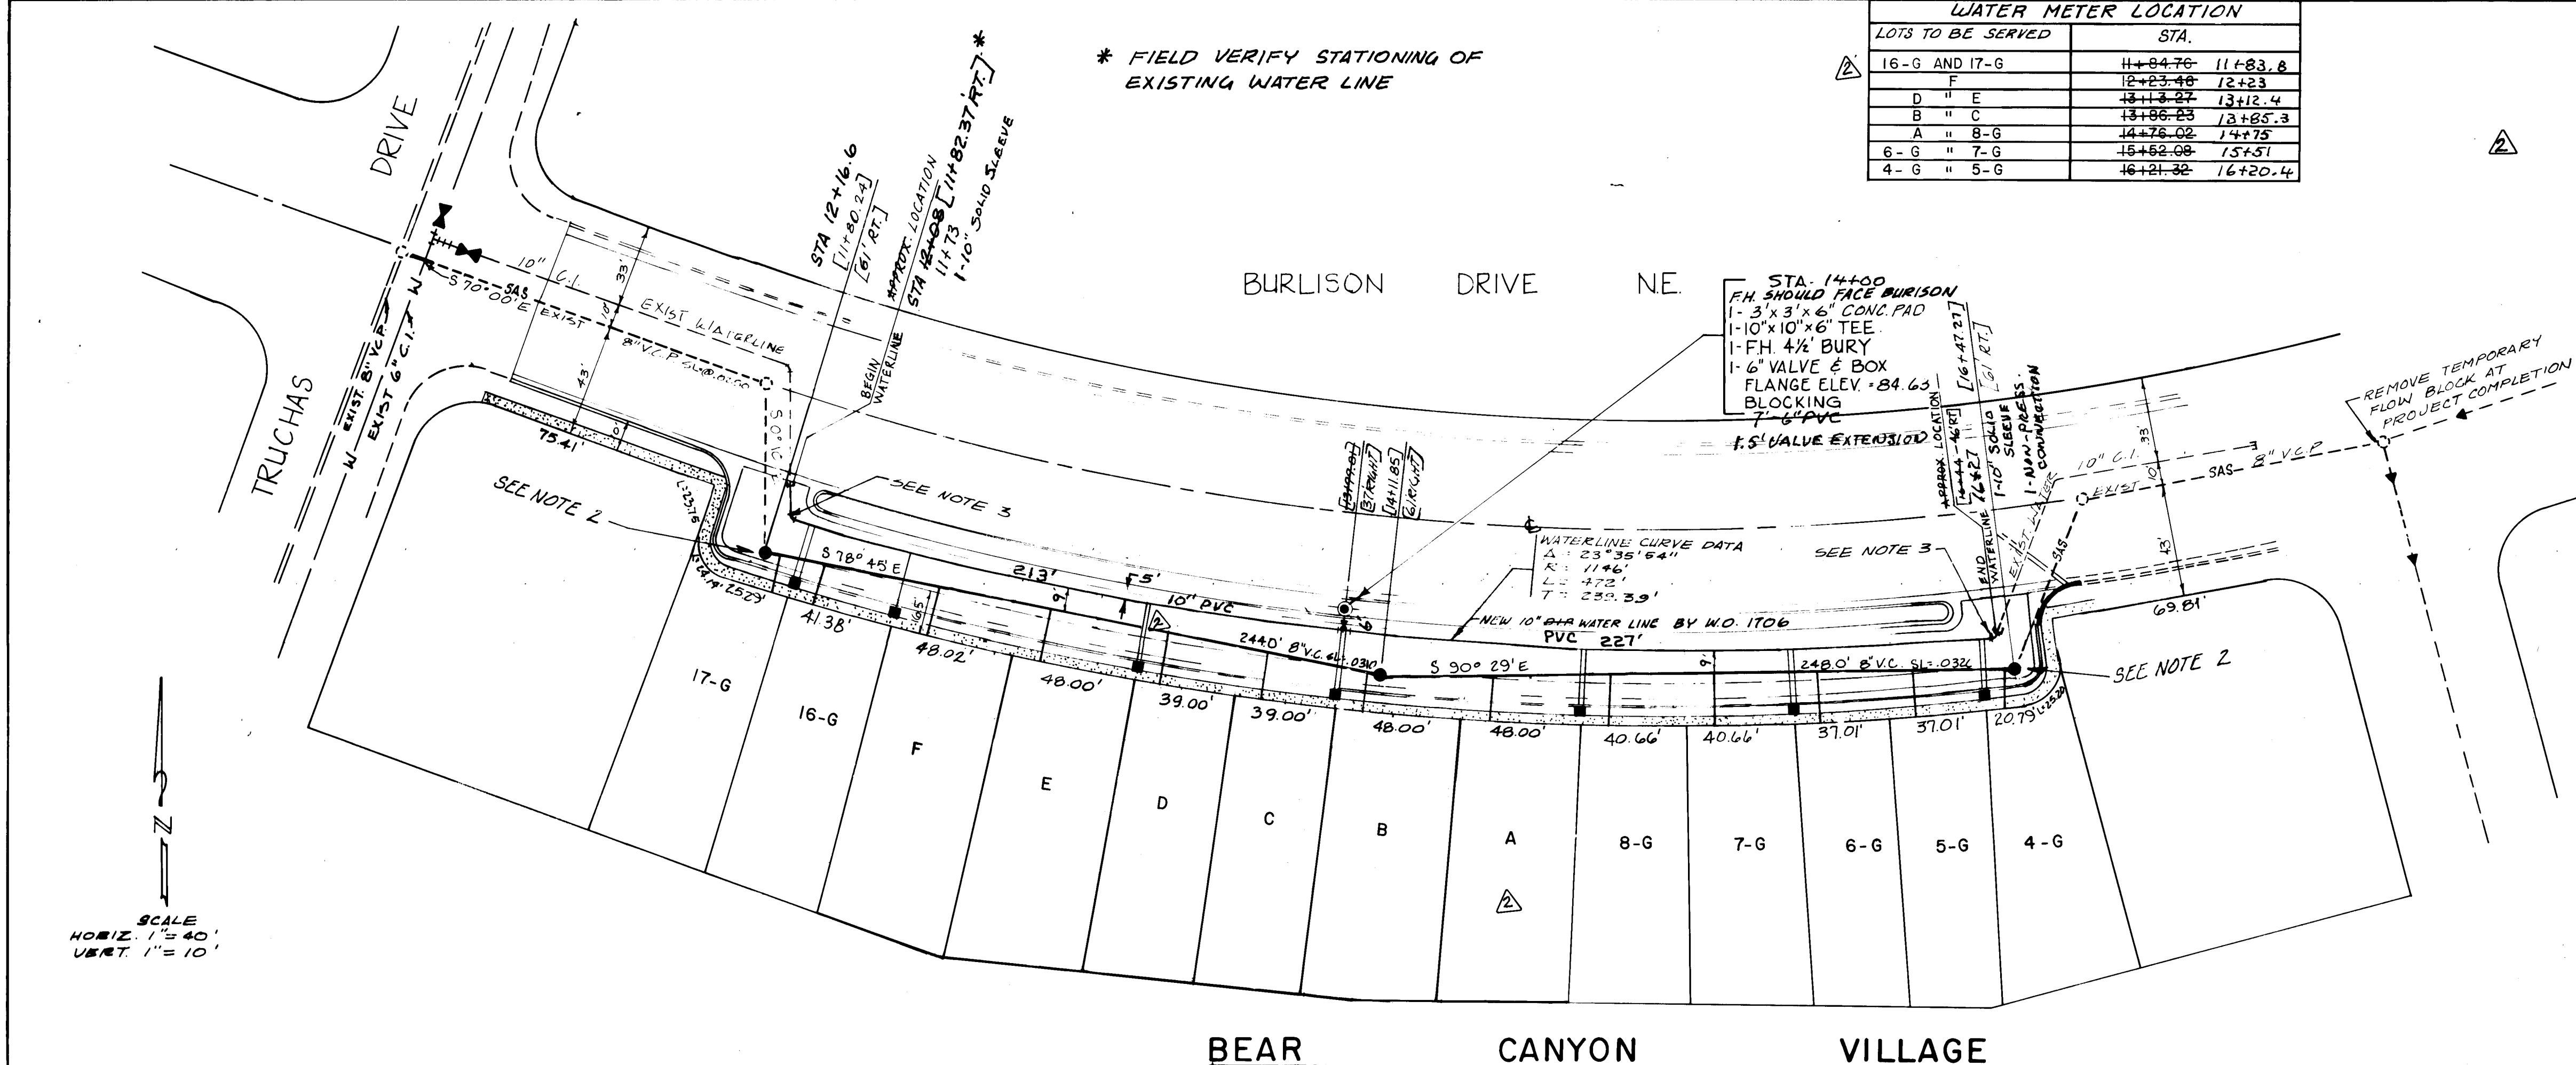

WATER METER LOCATION		
LOTS TO BE SERVED	STA.	
16-G AND 17-G	11+84.76	11+83.8
D	12+23.48	12+23
B	13+18.24	13+18.4
A	14+76.02	14+75.3
6-G	15+42.08	15+41
4-G	16+21.32	16+20.4

* FIELD VERIFY STATIONING OF EXISTING WATER LINE


STA. 14+00
FH SHOULD FACE BURLISON
1-3' x 3' x 6' CONC PAD
1-10' x 10' x 16' TEE
1-FH 4" BURY
1-6" VALVE & BOX
FLANGE ELEV. +84.63
BLOCKING
7-6" PVC
1-5" VALVE EXTENSION

WATERLINE CURVE DATA
Δ = 23° 35' 16.4"
R = 114.6'
L = 472'
T = 250.39'

NEW 10" DUAL WATER LINE BY W.O. 1706
PVC 227'

REMOVE TEMPORARY
FLOW BLOCK AT
PROJECT COMPLETION

BEAR CANYON VILLAGE

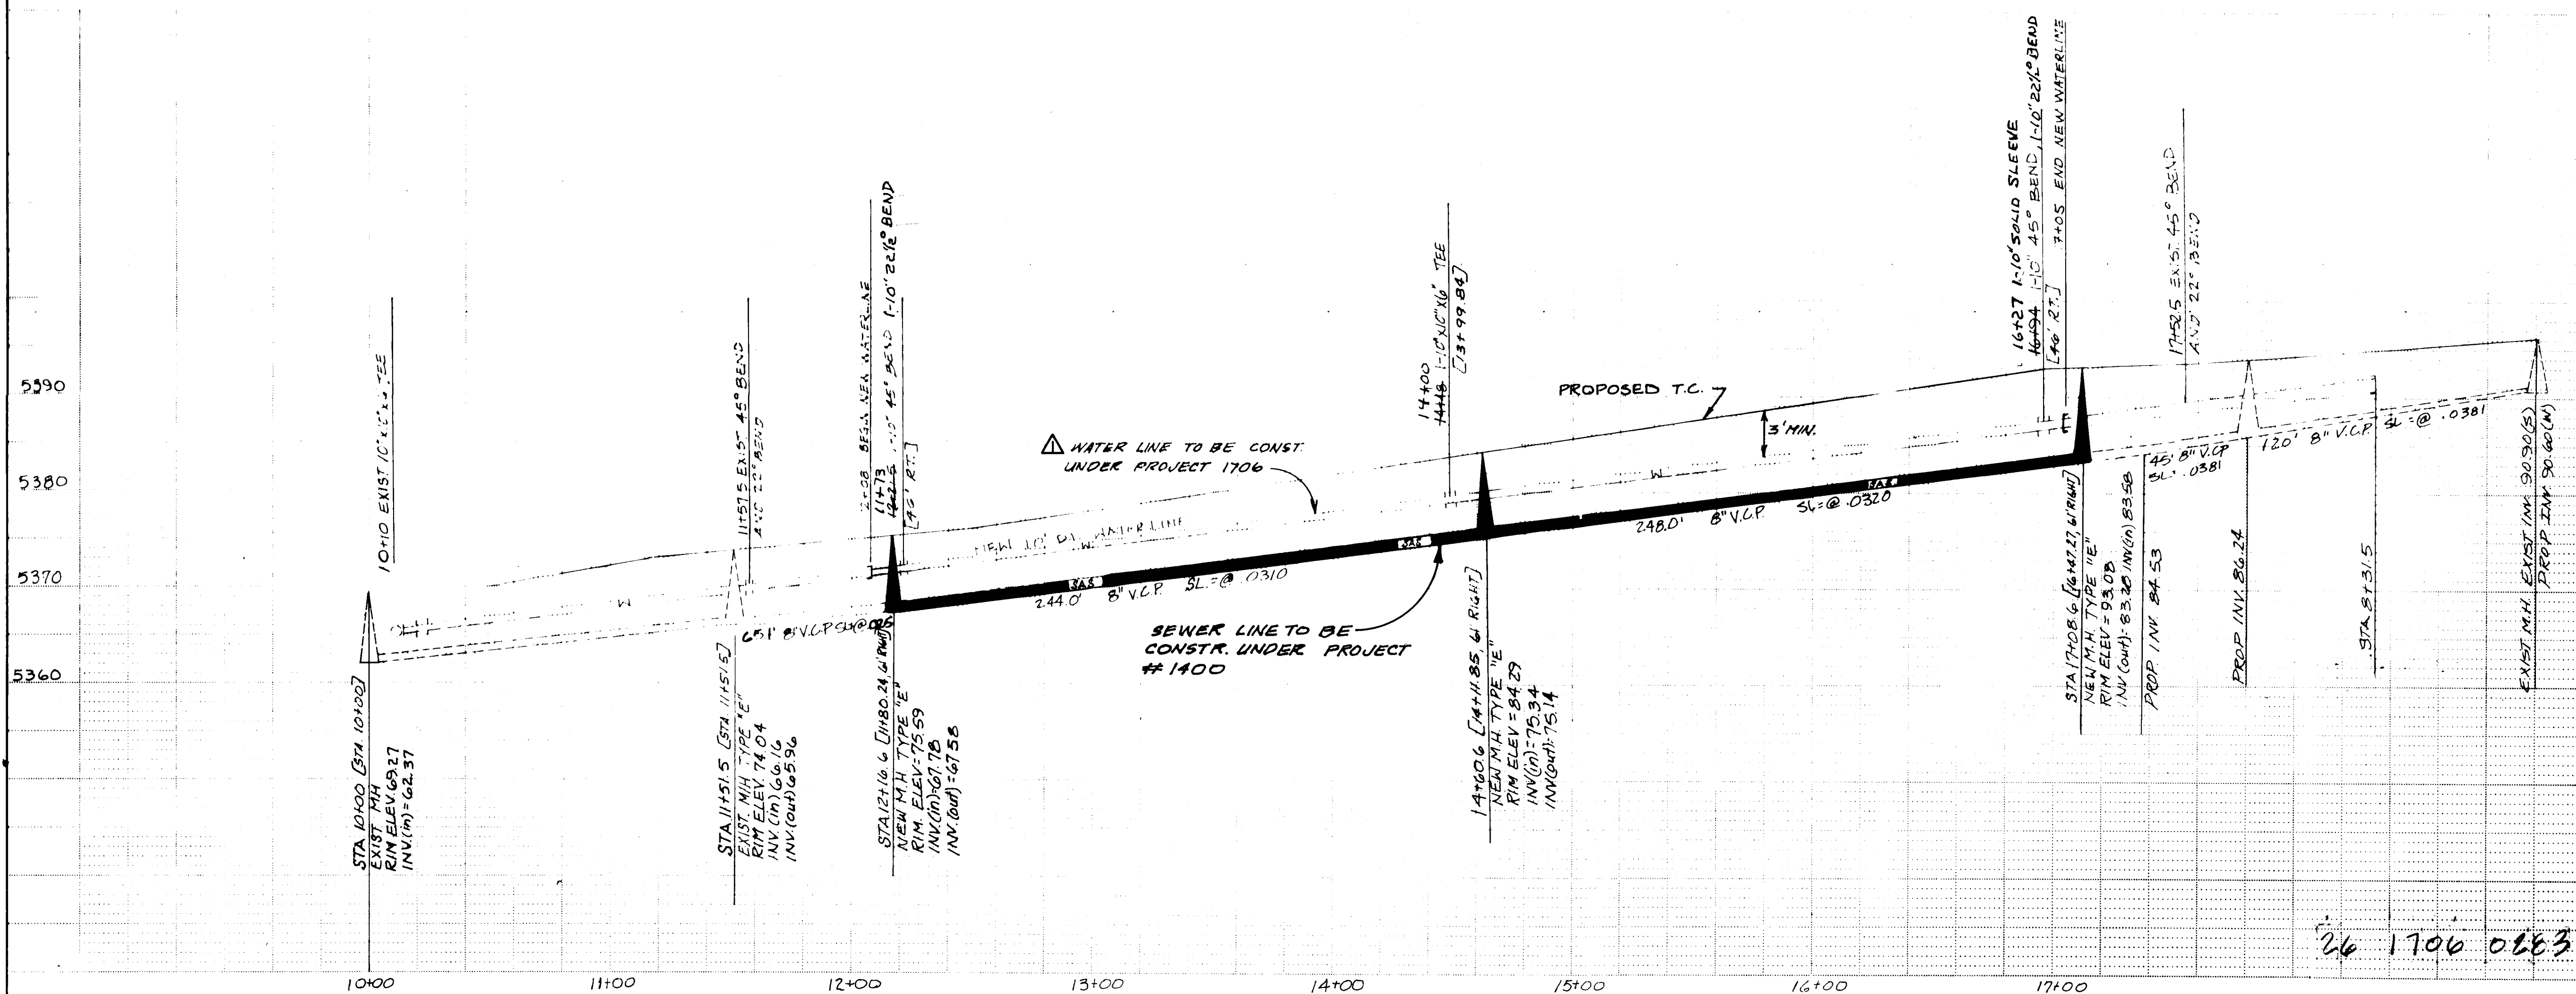

NOTES:

- STATIONING SHOWN ON THIS PLAN AND PROFILE IS ALONG EACH NEW PIPELINE INDIVIDUALLY EXCEPT WHEN ENCLOSED IN BRACKETS. STATIONING ENCLOSED IN BRACKETS REFERS TO STATIONING ALONG E OF BURLISON DR.
- BUILD NEW M/H OVER EXIST. STUB PLACE M/H SO AS NOT TO INTERFERE WITH NEW CURB AND GUTTER
- REMOVE & RETURN 10" CAP, INSTALL 10" 45° BEND AND BLK. REPLACE EXIST. END OR INSTALL NEW END. 1-10"-22 1/2° BEND

LEGEND:

- NEW MANHOLE TYPE "E"
- NEW 8" V.C. SAN SEWER LINE
- NEW FIRE-HYDRANT 4-1/2' BURY
- NEW 3/4" DUAL WATER METERS
- EXIST. MANHOLE
- EXIST. 8" V.C. SAN SEWER LINE
- EXIST. 10" C.I. WATER LINE

SEWER LINES TO BE CONSTRUCTED UNDER PROJECT NO. 1400.

APPROVED FOR CONSTRUCTION
CITY ENGINEER 3/31/83 DATE

CITY OF ALBUQUERQUE
MUNICIPAL DEVELOPMENT DEPARTMENT
ENGINEERING DIVISION

TITLE: WATER PLAN FOR BEAR CANYON VILLAGE BURLISON DR.

APPROVALS	ENGINEER	DATE	APPROVALS	ENGINEER	DATE
City Engineer	R. R. R.	9/1/82	Public Works	R. R. R.	9/1/82
A.C.E. - Design	R. R. R.	9/1/82	Traffic	R. R. R.	9/1/82
A.C.E. - Hydrology	R. R. R.	9/1/82	Water	R. R. R.	9/1/82
QA	R. R. R.	9/1/82			

DRAWING NO. 1706 MAP NO. E-19 SHEET 2 OF 2