


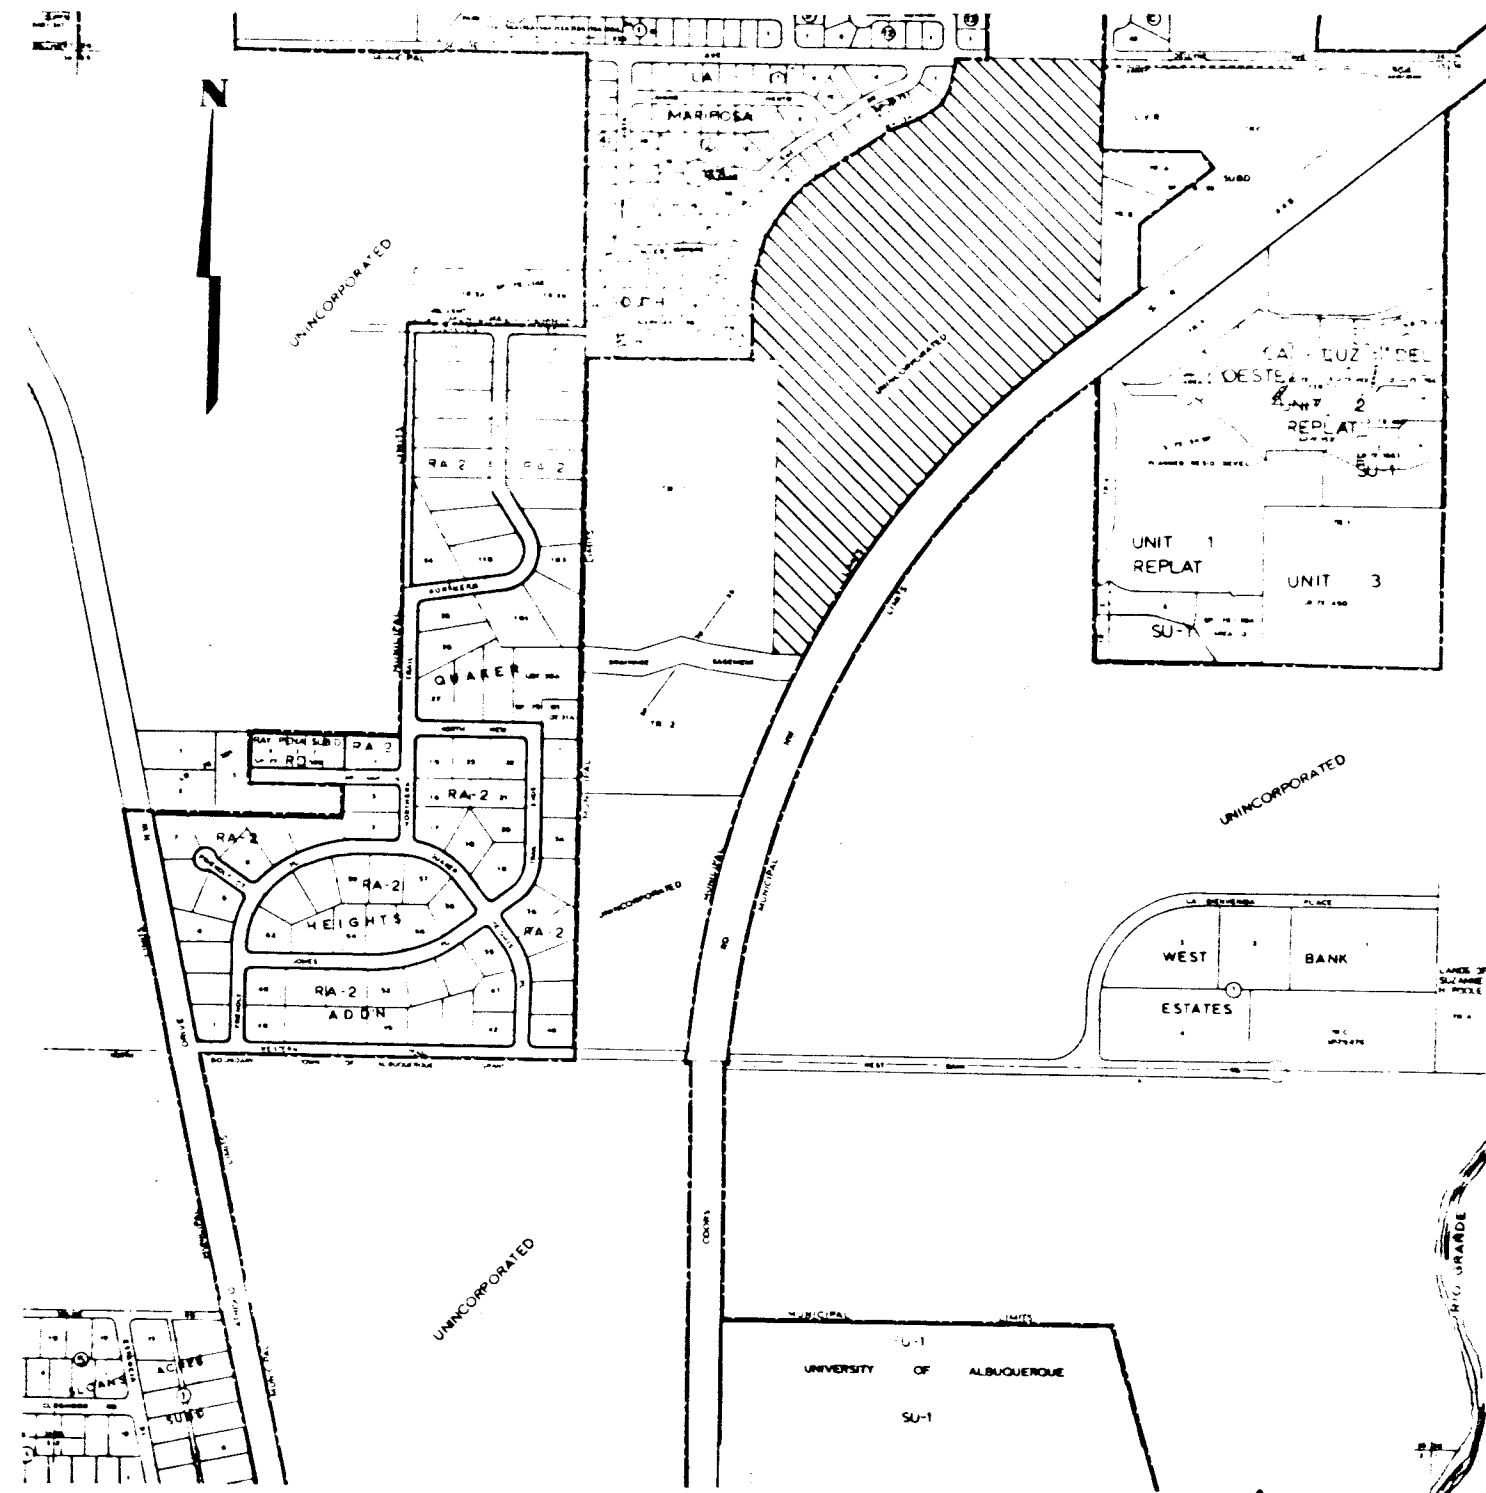

VICINITY MAP No. F-11



LA LUZ DEL OESTE

UNIT - 4 PHASE V

INDEX


DESCRIPTION	SHEET NO.
TITLE SHEET	1
DETAILS	2-3
GRADING PLAN	4
PAVING LAYOUT	5
WATER LAYOUT	6
PLAN & PROFILE - PAVING & WATER	7
ROAD PROFILES	8

GENERAL NOTES

1. New Mexico Specifications for Public Works Construction-1979 Edition, will be referred to hereon as the "Standard Specification".
2. All work detailed on these plans to be performed under contract shall, except as otherwise stated or provided for hereon, be constructed in accordance with "Contract Documents for City-Wide Utilities and Cash Paving No.31 and the Standard Specifications".
3. All utilities and utility service lines shall be installed prior to paving.
4. Where a water line passes beneath or less than 3' above an existing sewer line, the sewer line shall be encased in concrete 6" thick for at least 10' on each side of the water line, or the sewer line shall be replaced with ductile iron pipe with mechanical joints for 10' each side of the water line. This shall also apply where a parallel water line is less than 10' horizontally and less than 2' above the sewer.
5. Backfill compaction shall be according to specified street use.
6. Tack coat requirements shall be determined by the Engineer.
7. Two working days prior to any excavation, contractor must contact Line Locating Service, 765-1234, for location of existing utilities.
8. Prior to construction, the contractor shall excavate and verify the horizontal and vertical locations of all obstructions. Should a conflict exist, the contractor shall notify the engineer or surveyor so that the conflict can be resolved with a minimum amount of delay.
9. Location of Flattened Crown Sections as specified by the engineer.

APPROVED FOR CONSTRUCTION - PHASE V

C. D. Delaney *H. J. Bordenave*
CITY ENGINEER DATE

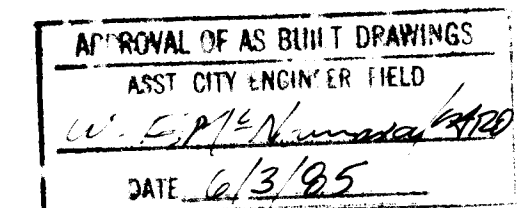


R. S. Allen *7/11/79*
CITY ENGINEER - CITY OF ALBUQUERQUE, NEW MEXICO DATE
Approved for drainage, grading & PUBLIC WATER SYSTEM ONLY






J. J. Bordenave *7/6/79*
J.J. BORDENAVE, N.M.P.E. & L.S. NO. 5110 DATE

T.T. Burnett Engineering, Inc.
120 Morningside N.E.
Albuquerque, New Mexico

26 18900185

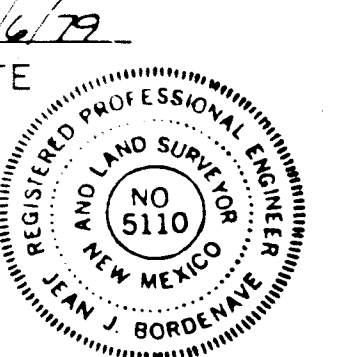

1890

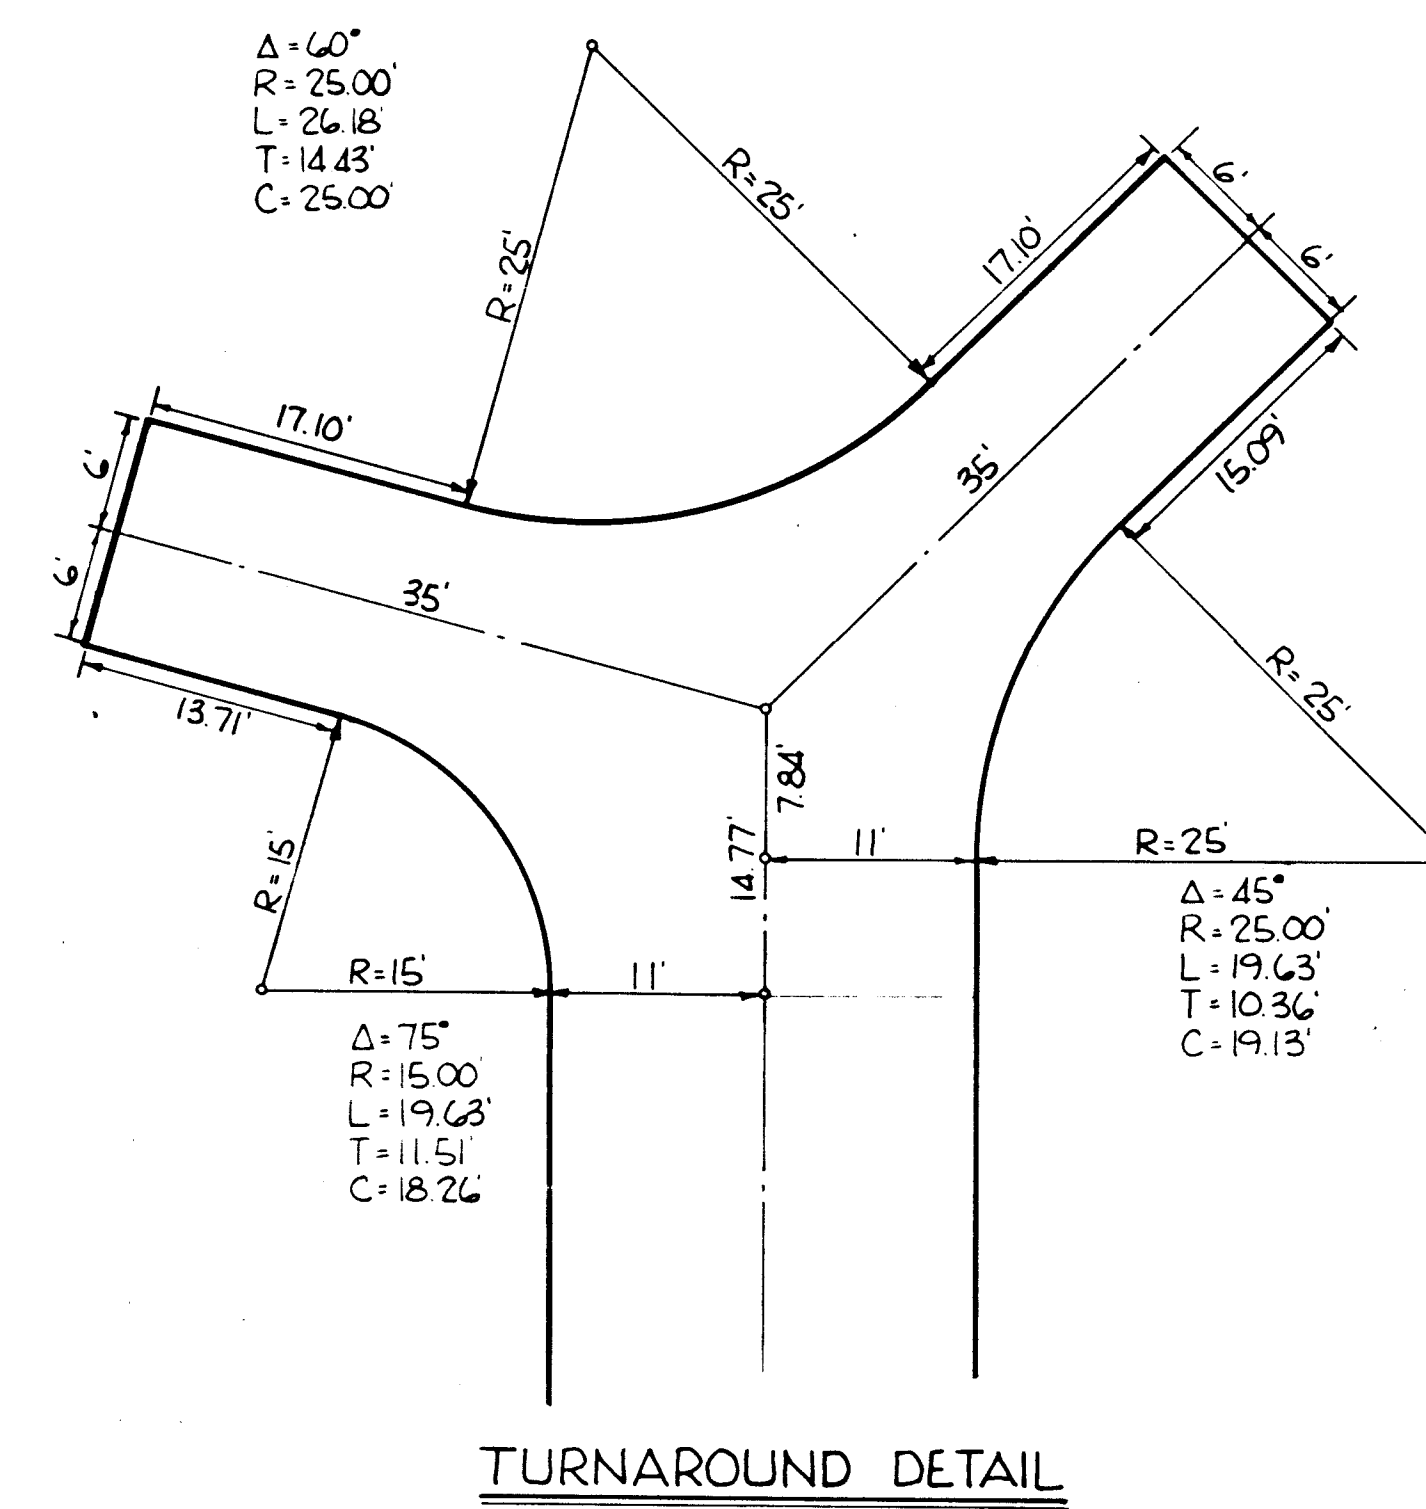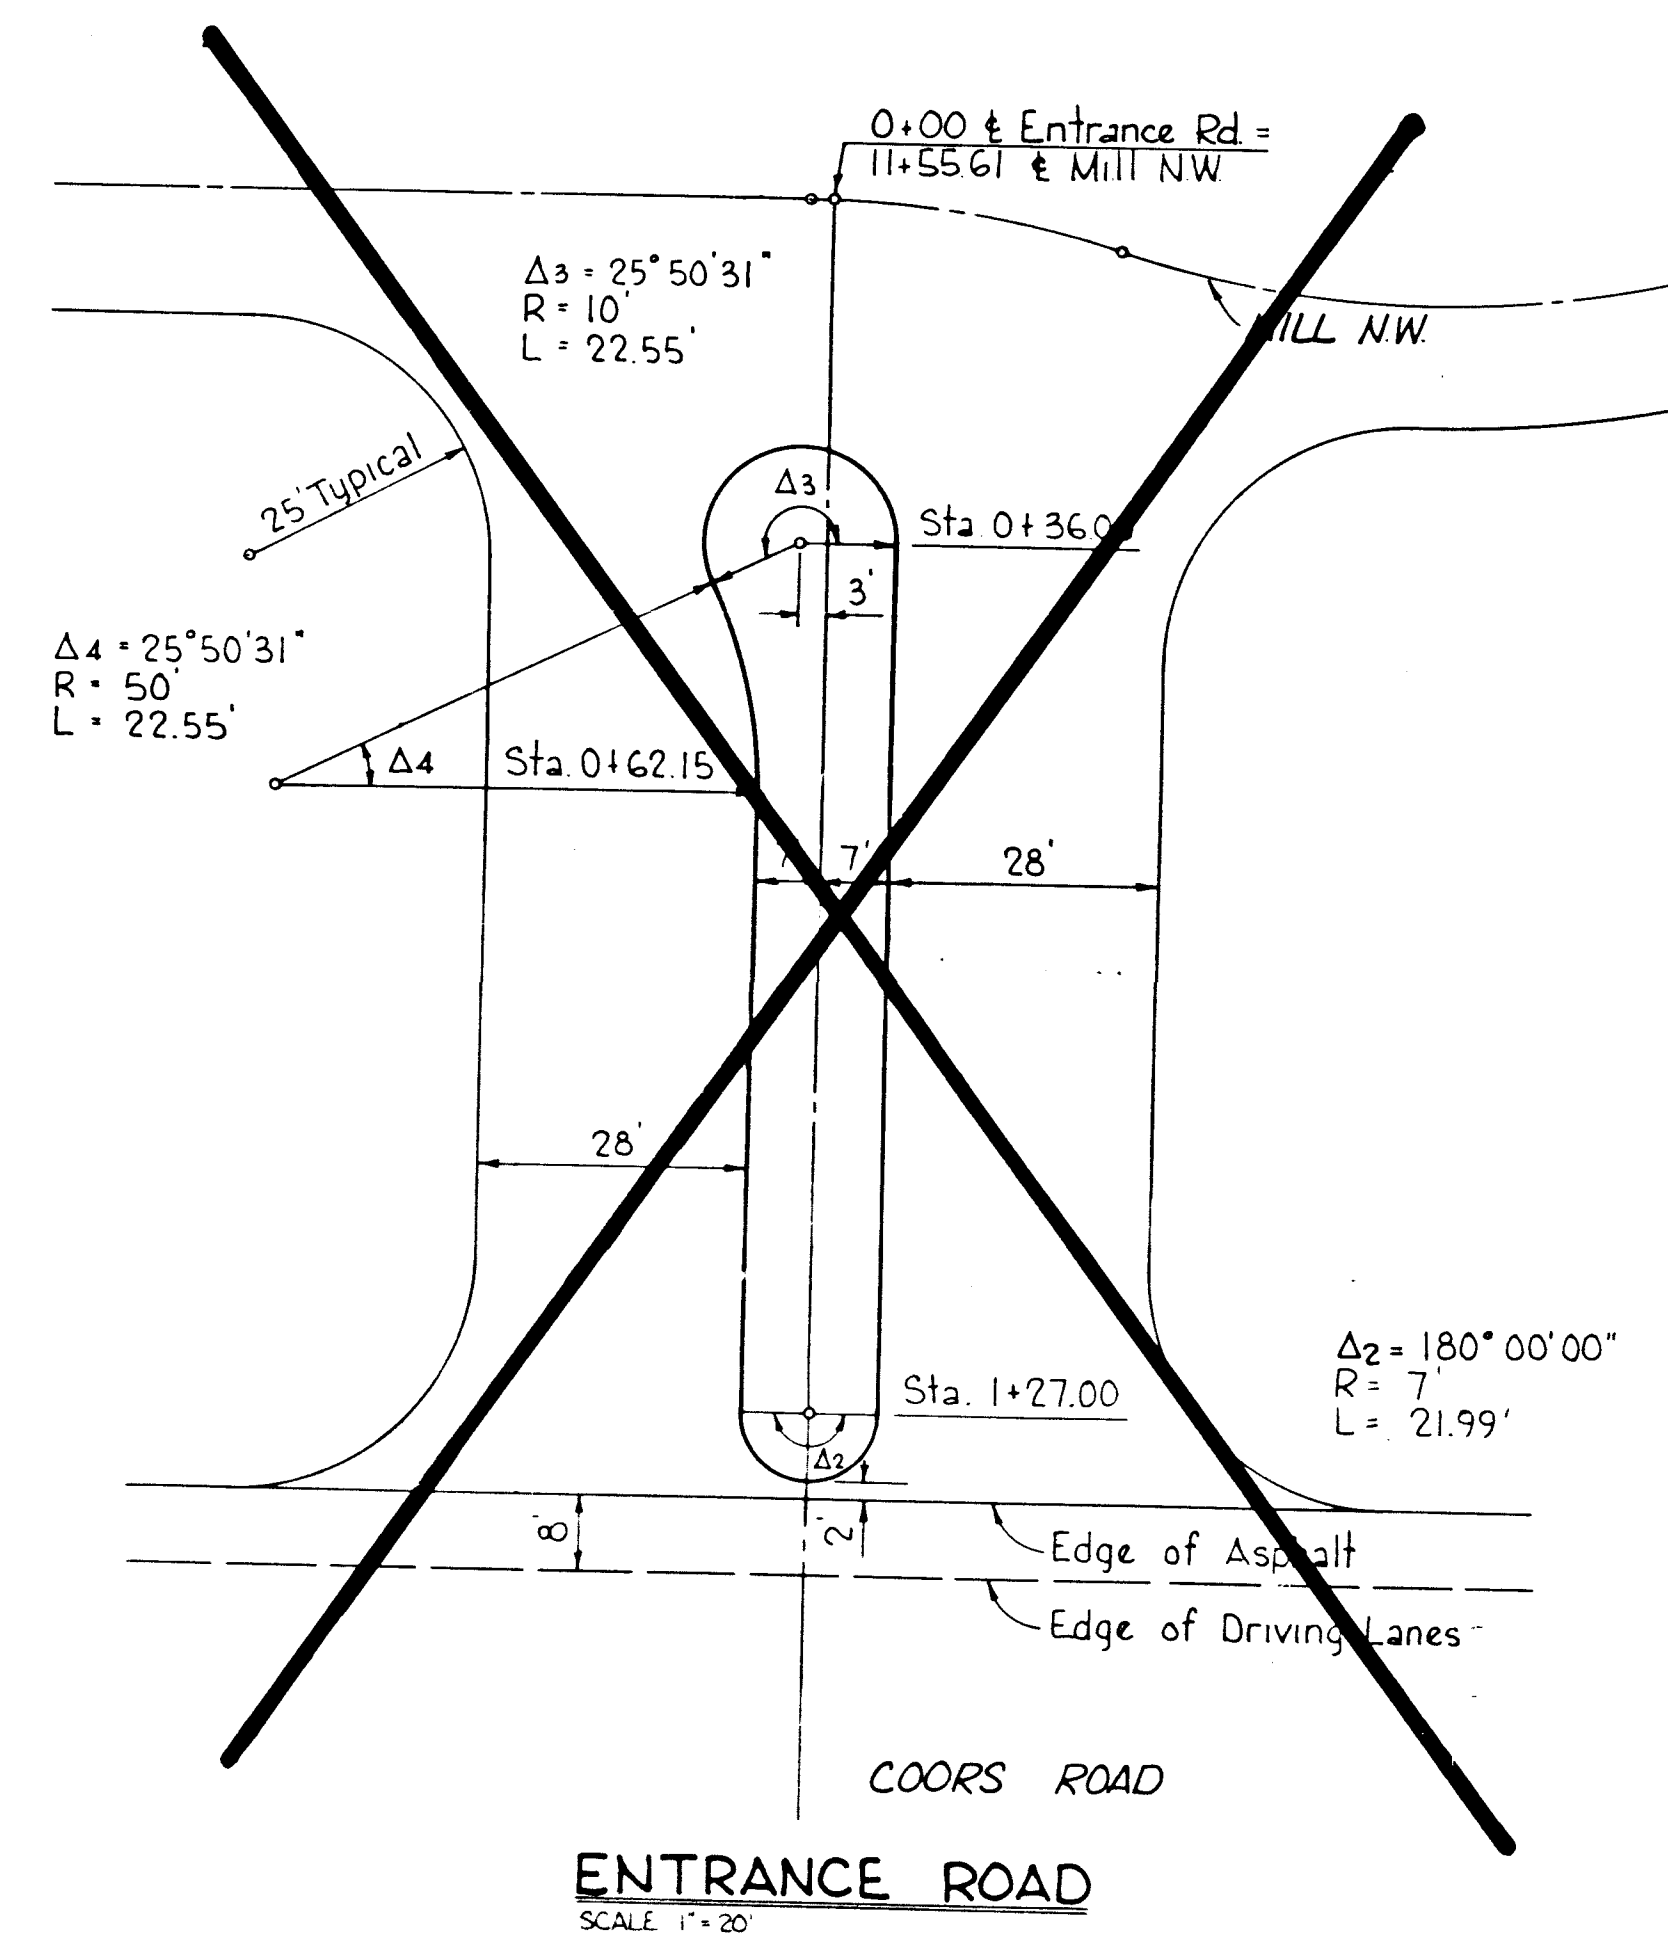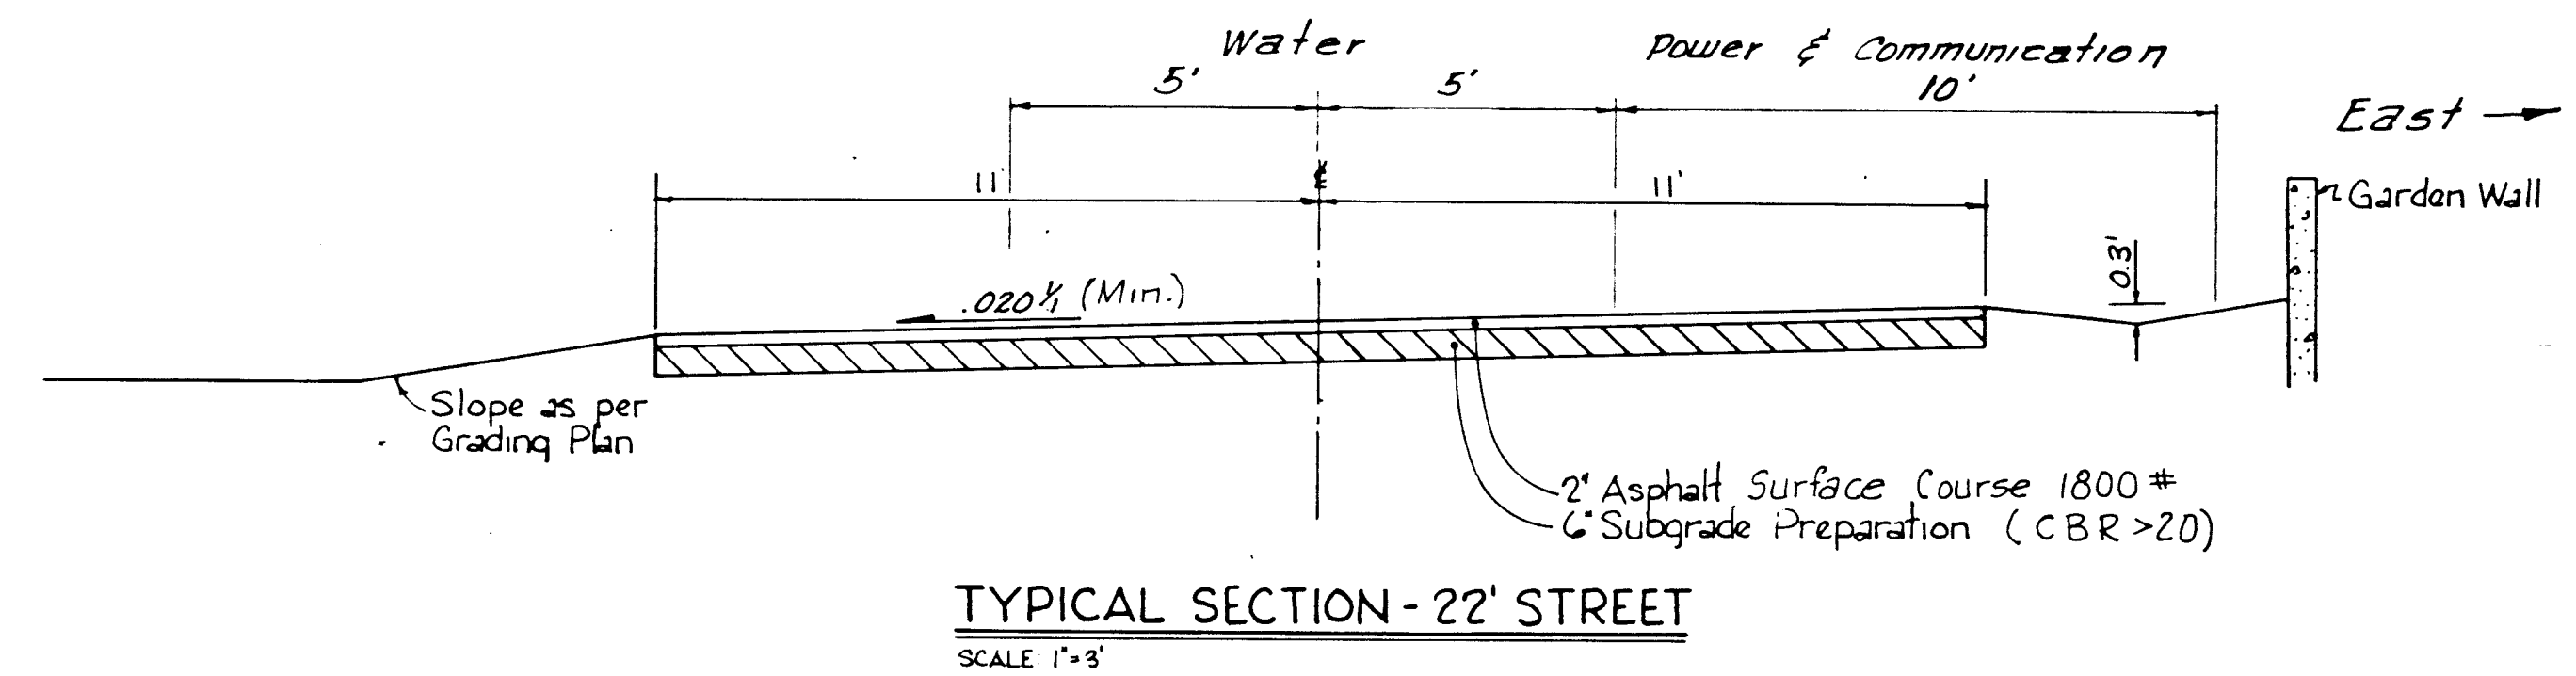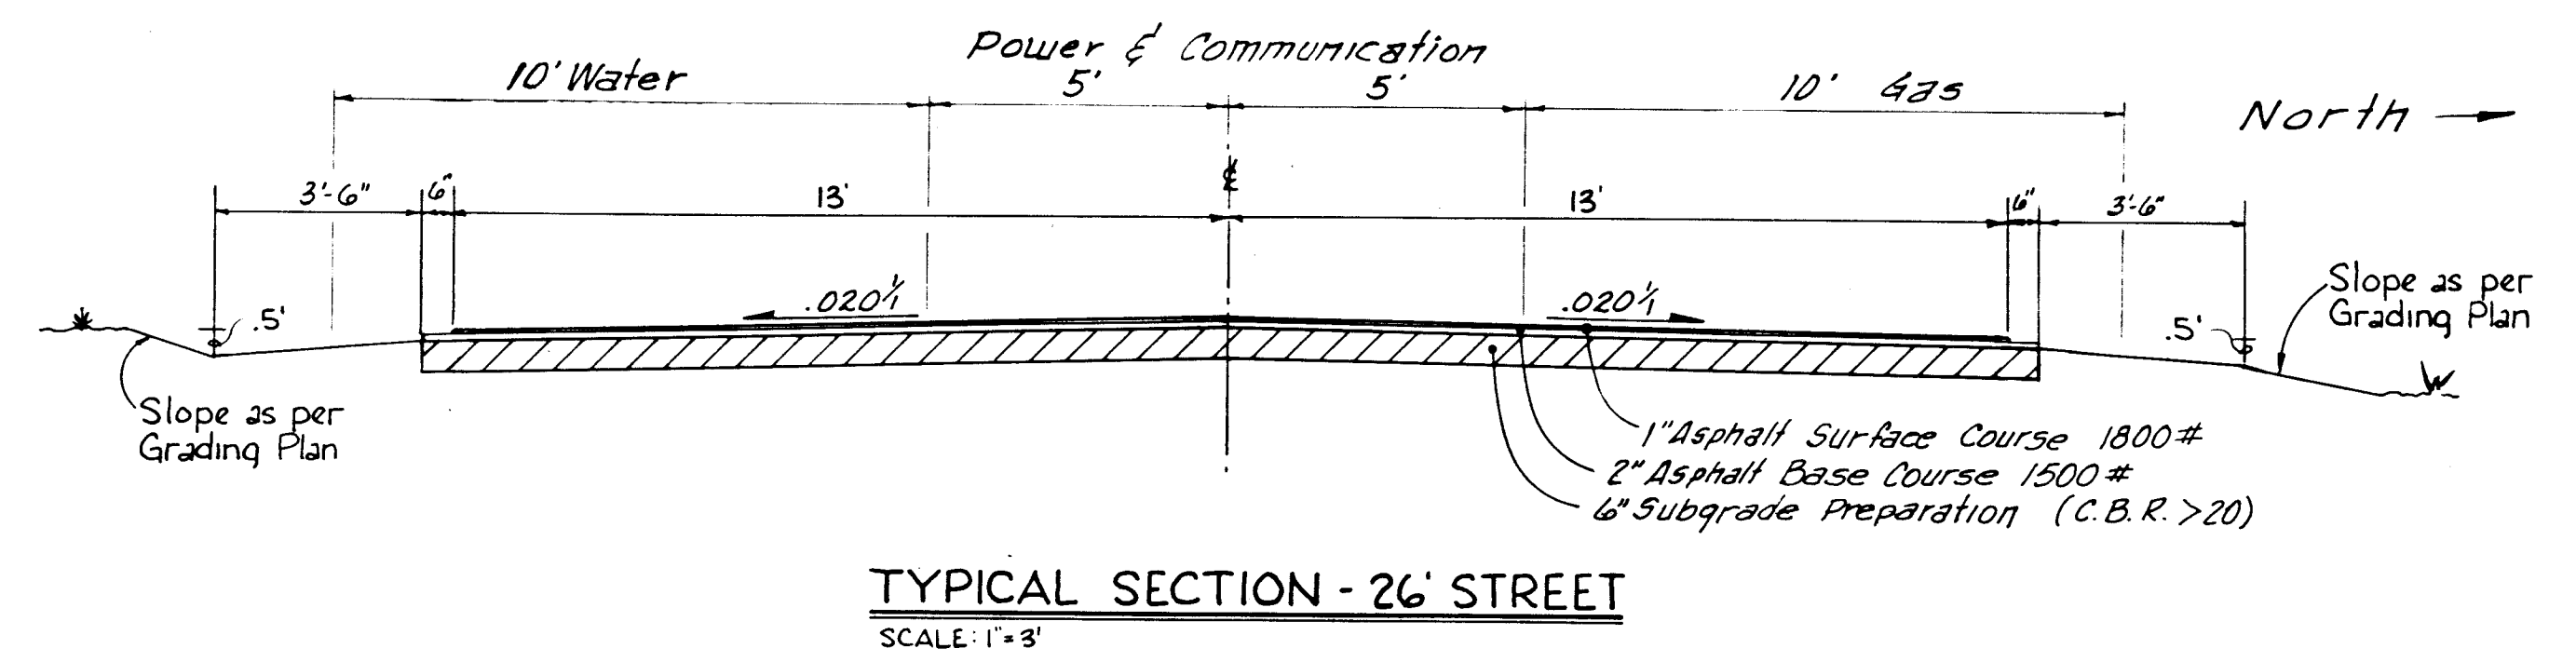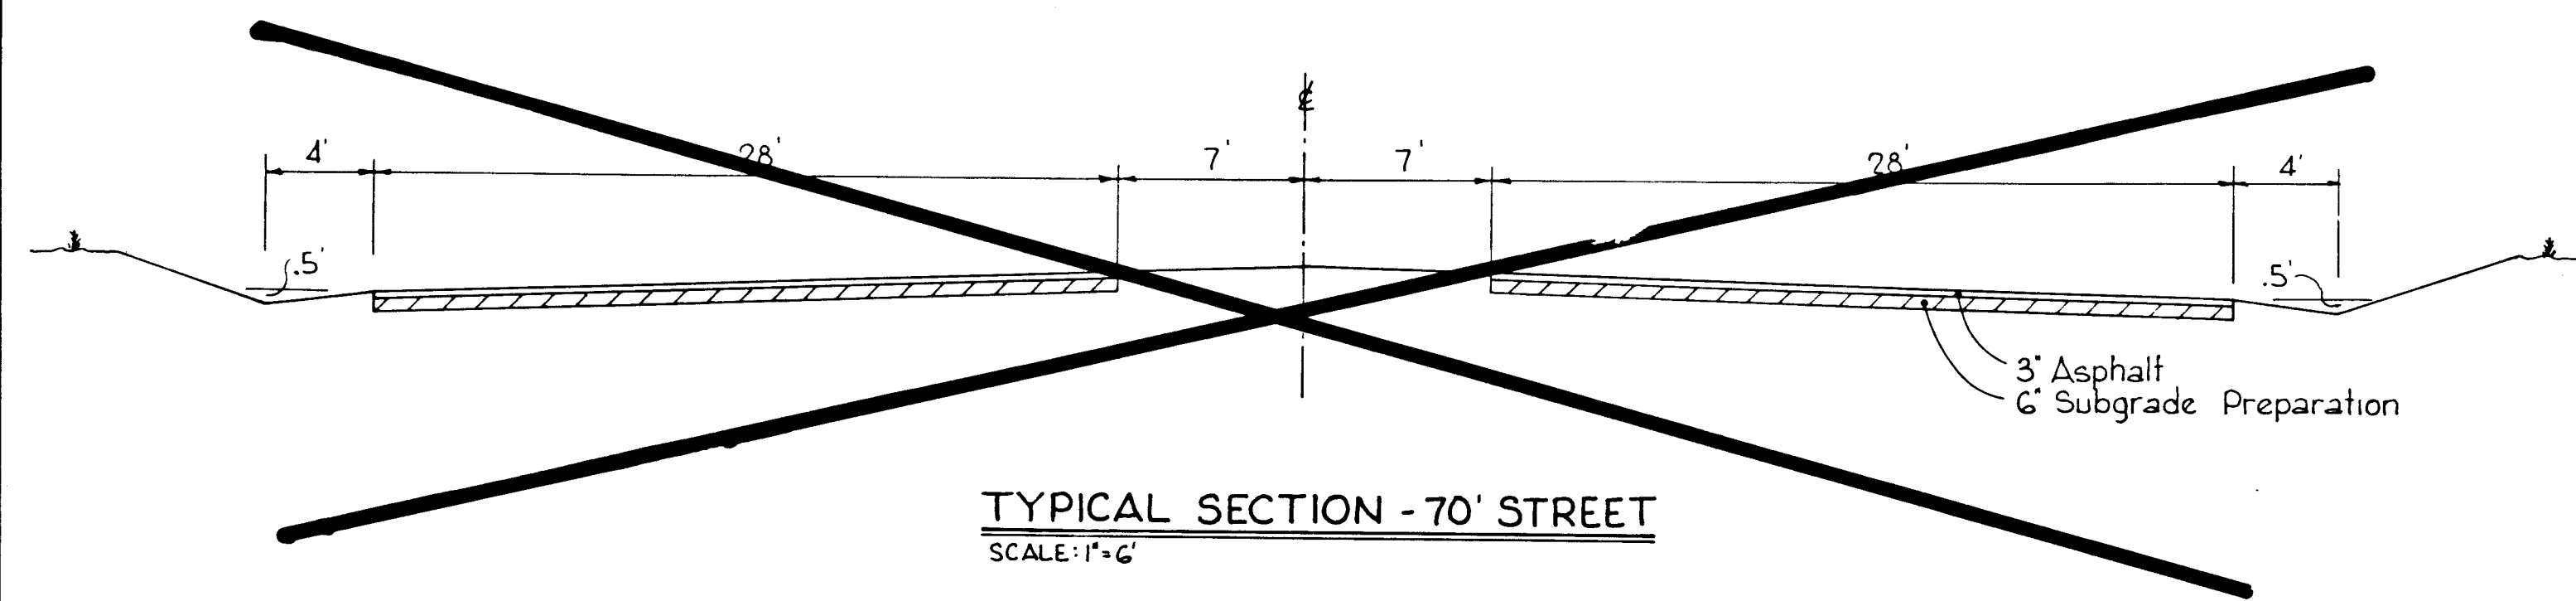[illegible]

ERQUE
 ARTMENT
 VISION

UNIT 4

V
 OVALS
 Waste

ENGINEER	DATE
NA	10/12/2017
NA	10/12/2017
NA	10/12/2017

SHEET 2 OF 8

CITY OF ALBUQUERQUE PUBLIC WORKS DEPARTMENT ENGINEERING DIVISION					
TITLE: LA LUZ DEL OESTE UNIT 4 DETAILS - PHASE V					
APPROVALS	ENGINEER	DATE	APPROVALS	ENGINEER	DATE
City Engineer	<i>[Signature]</i>	11/19/77	Liquid Waste	<i>NA</i>	11/23/77
A.C.E. Design	<i>[Signature]</i>	11/16/77	T. effluent	<i>[Signature]</i>	11/23/77
A.C.E. Hydrology	<i>[Signature]</i>	11/16/77	Water	<i>NA</i>	11/23/77
DRAWING NO. 1890			SHEET 2 OF 8		

2	3	4	5	6	7	8	9	10	11	12
2	6		1	8	9	0	0	3	8	5

CITY OF ALBUQUERQUE PUBLIC WORKS DEPARTMENT ENGINEERING DIVISION					
TITLE LA LUZ DEL OESTE UNIT 4 TYPICAL YARD GRADING DETAILS-PHASE V					
APPROVALS	ENGINEER	DATE	APPROVALS	ENGINEER	DATE
City Engineer	<i>[Signature]</i>		Liquid Waste	<i>[Signature]</i>	7/27
A.C.E. Design	<i>[Signature]</i>	1/16/79	Traffic	N.A.	
Hydrology	<i>[Signature]</i>	7/16/79	Water	<i>[Signature]</i>	7/27
DRAWING NO. 1890			SHEET 3 OF 8		

[illegible]

APPROVED FOR ROUGH
GRADING $\pm 1'$


CITY ENGINEER _____ DATE _____

CITY OF LOS ANGELES
PUBLIC WORKS DEPARTMENT
ENGINEER

9/11/63

N.A. *Ret.*


Scale 1" = 50'

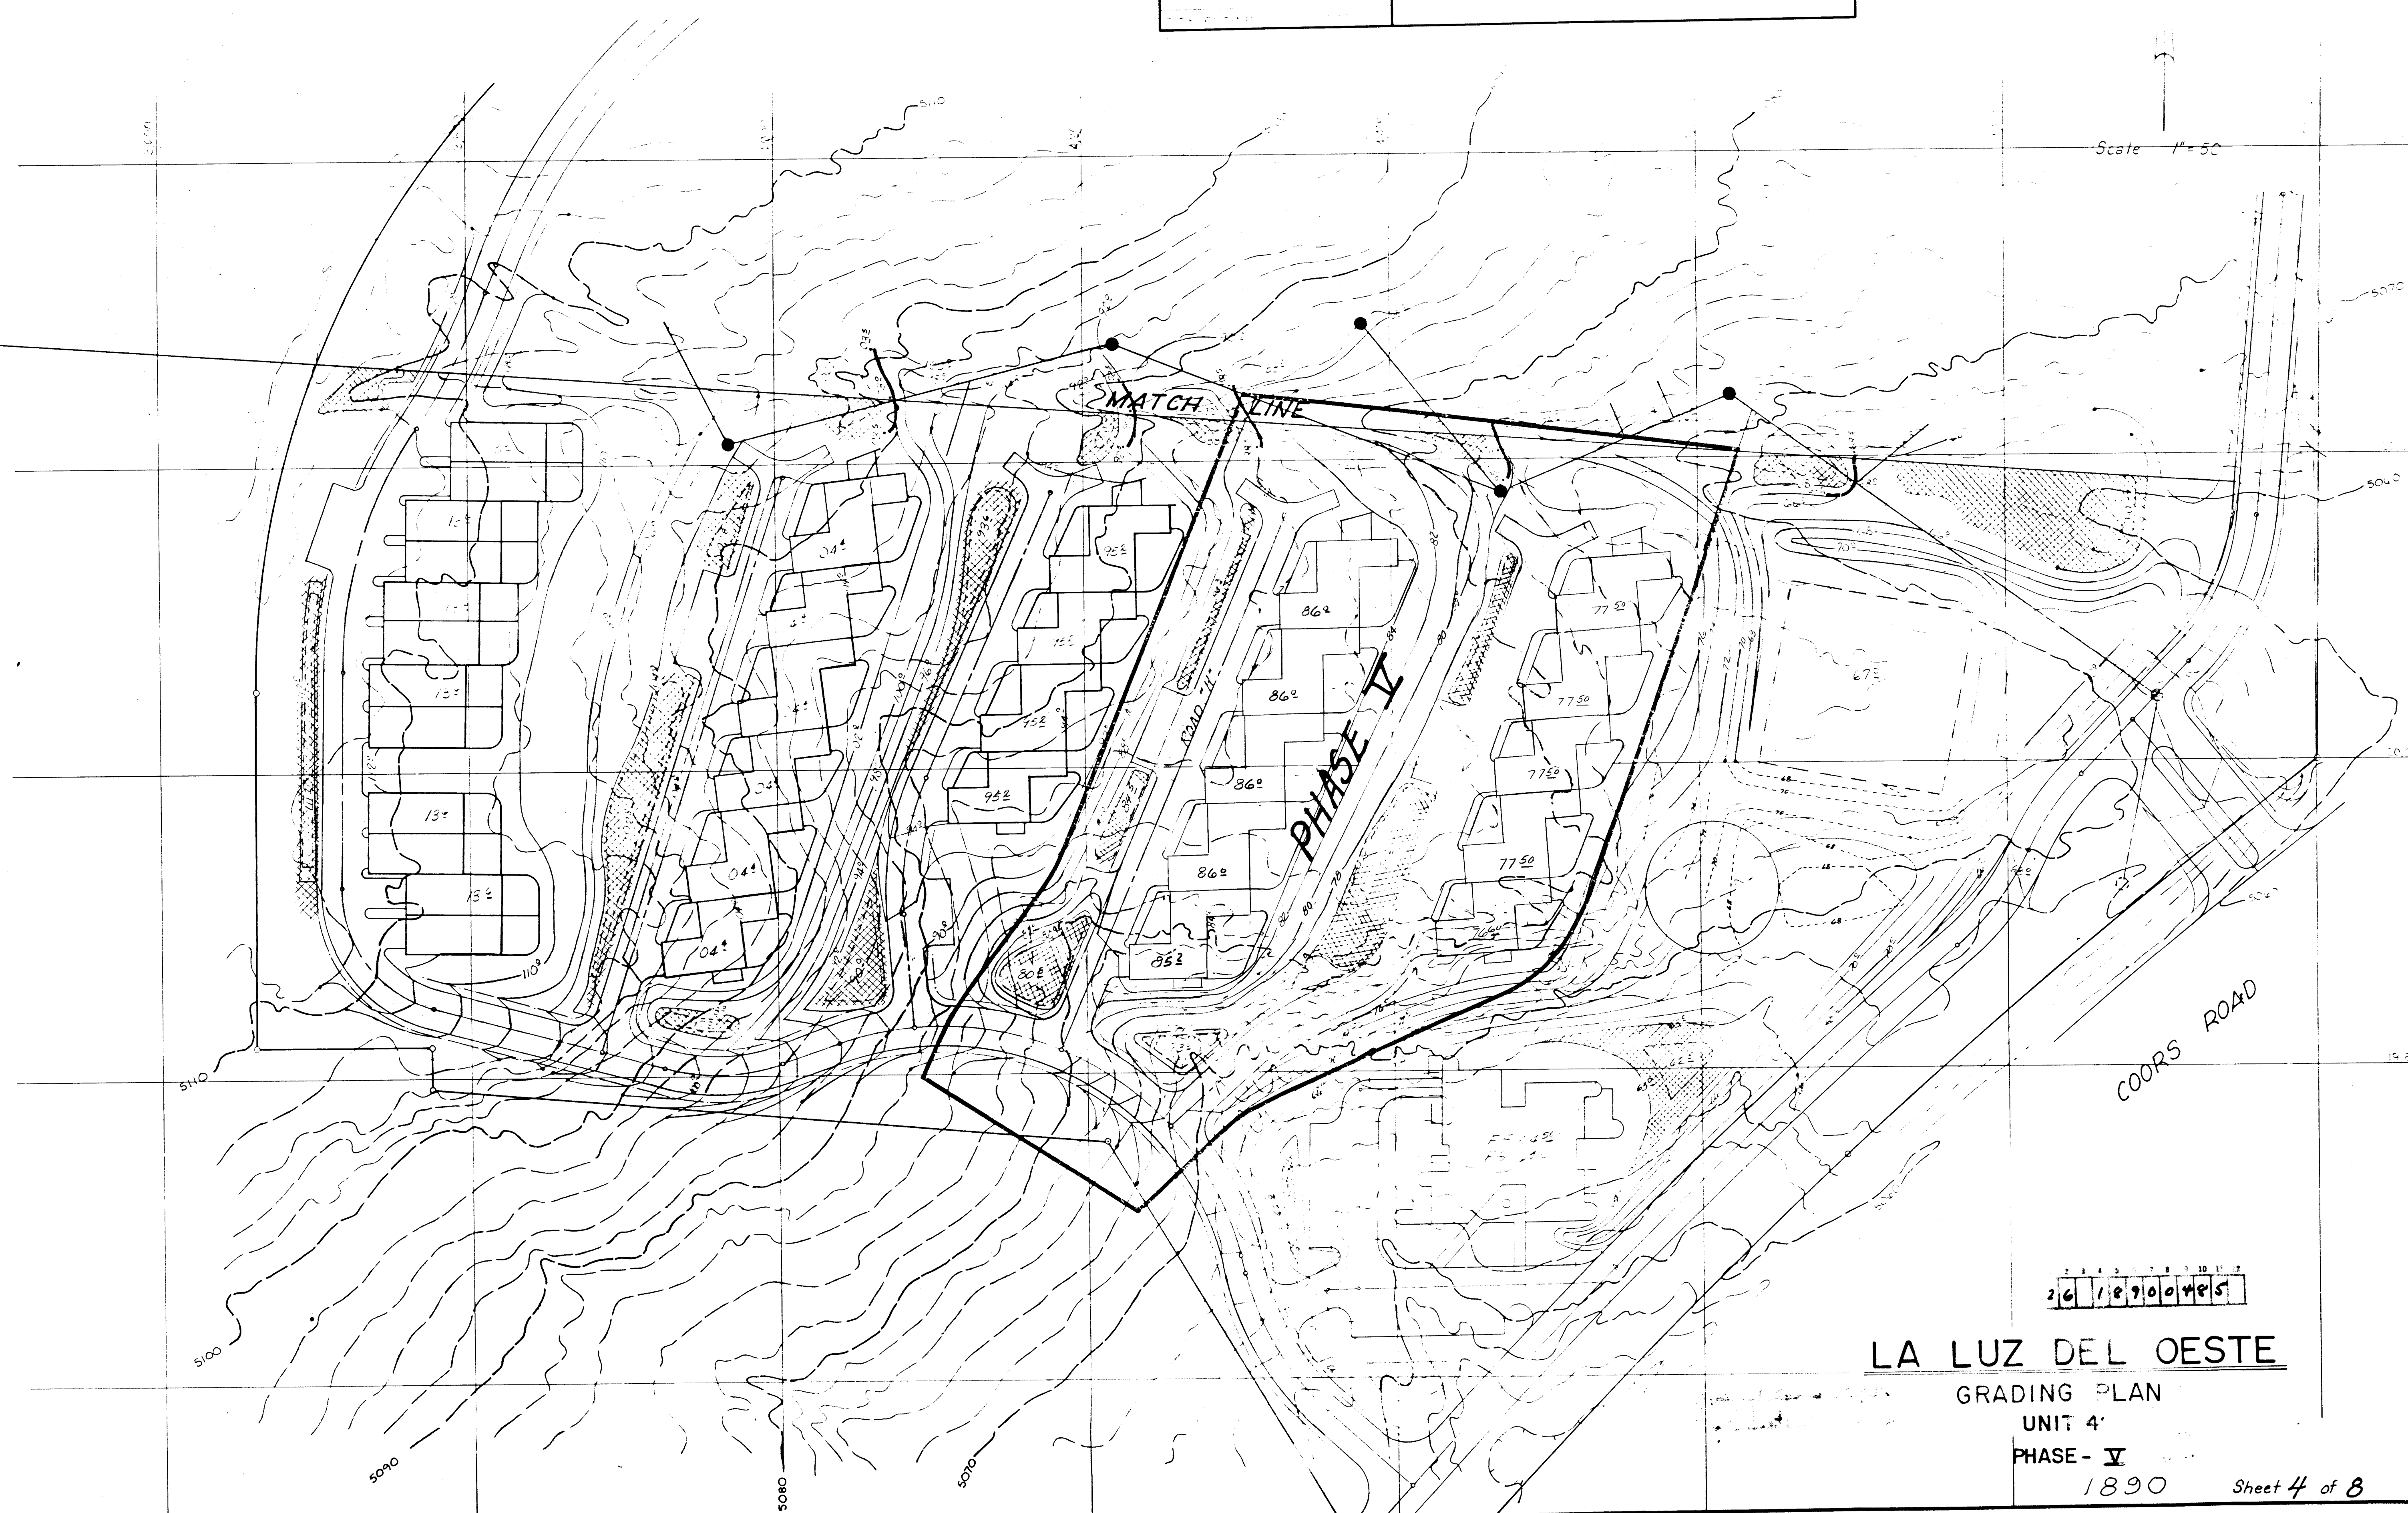

26 1890 465

LA LUZ DEL OESTE
GRADING PLAN
UNIT 4
PHASE - V
1890 Sheet 4 of 8

0881

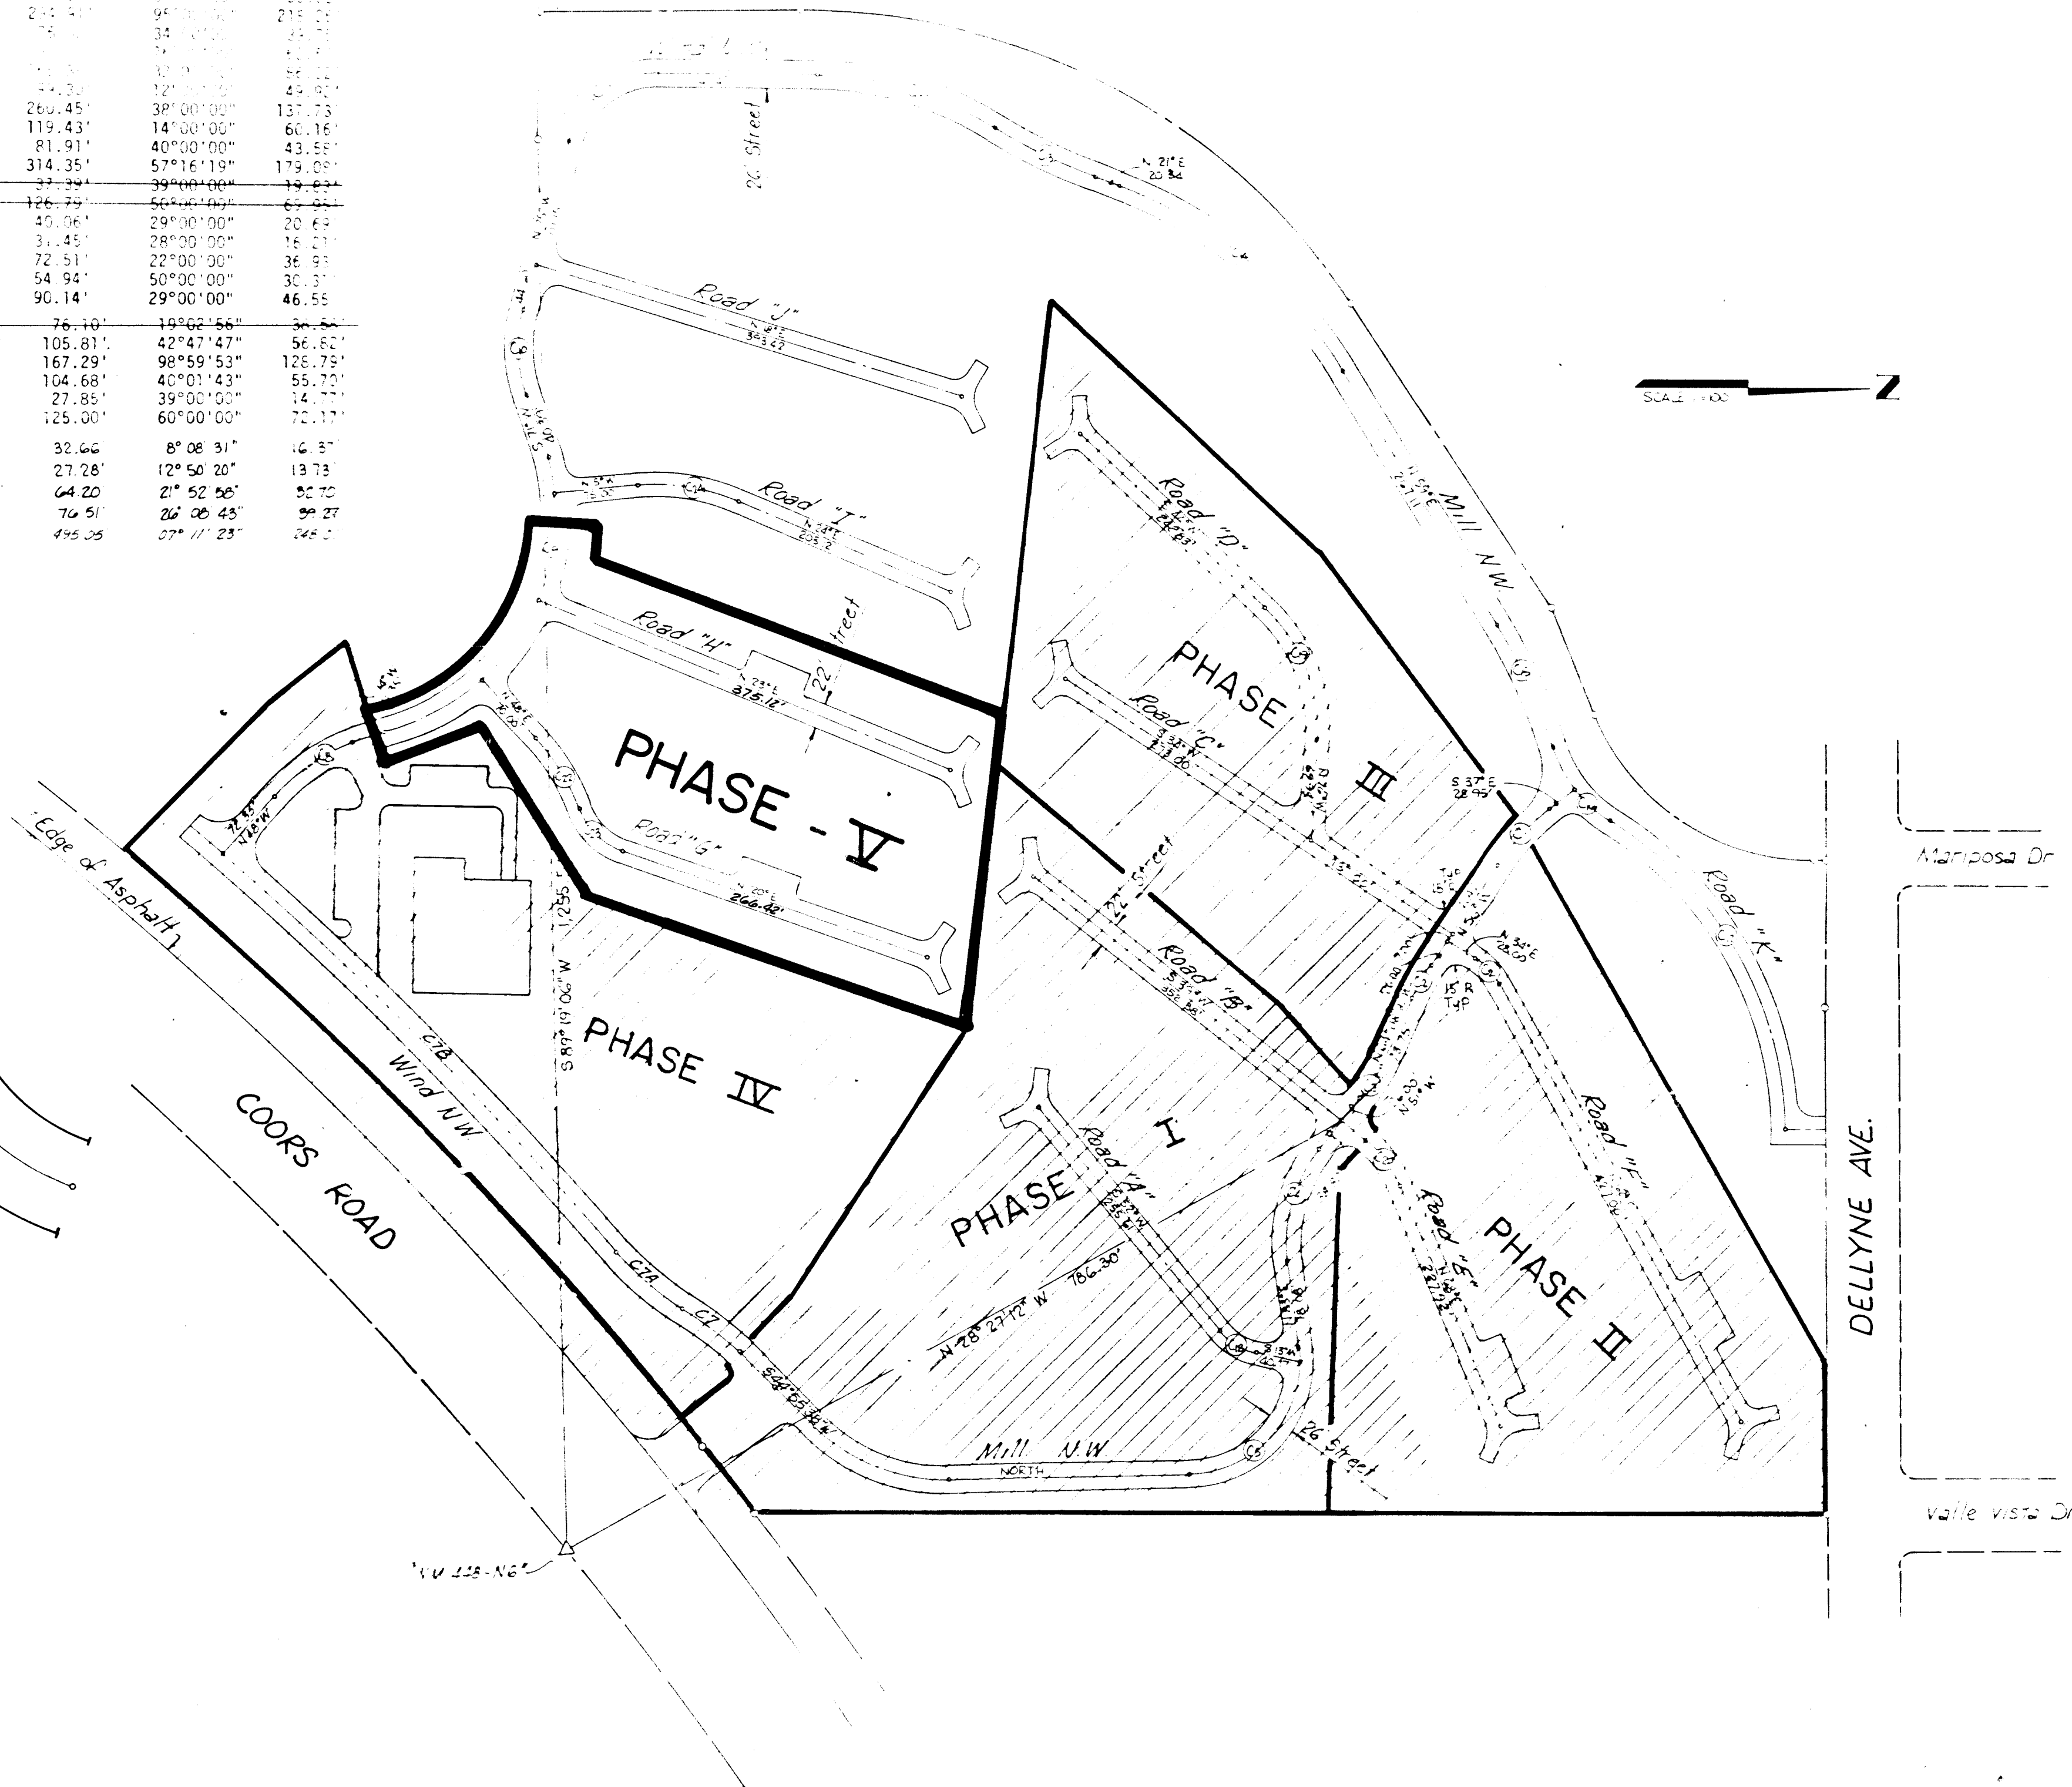
A diagram of a building layout, possibly a floor plan, with a large 'X' drawn over it, indicating a rejected or incorrect design. The layout includes several rectangular rooms of varying sizes, some with internal partitions, and a central corridor. The lines are thin and black on a white background.

CITY OF ALBUQUERQUE PUBLIC WORKS DEPARTMENT ENGINEERING DIVISION				
TITLE LA LUZ DEL OESTE UNIT 4 PAVING LAYOUT PHASE - I				
APPROVALS	ENGINEER	DATE	APPROVALS	ENGINEER
City Engineer	<i>[Signature]</i>	<i>11/1/78</i>	Liquid Waste	<i>NA</i>
A.C.E. Design	<i>[Signature]</i>	<i>11/1/78</i>	Traffic	<i>NA</i>
A.C.E. Hydrology	<i>[Signature]</i>	<i>11/1/78</i>	Water	<i>NA</i>
DRAWING NO. 1890			SHEET 5 OF 8	


APPROVED FOR CONSTRUCTION	
CITY ENGINEER	DATE

DRAWING NO.	1890	SHEET 5 OF 8
-------------	------	--------------

1890


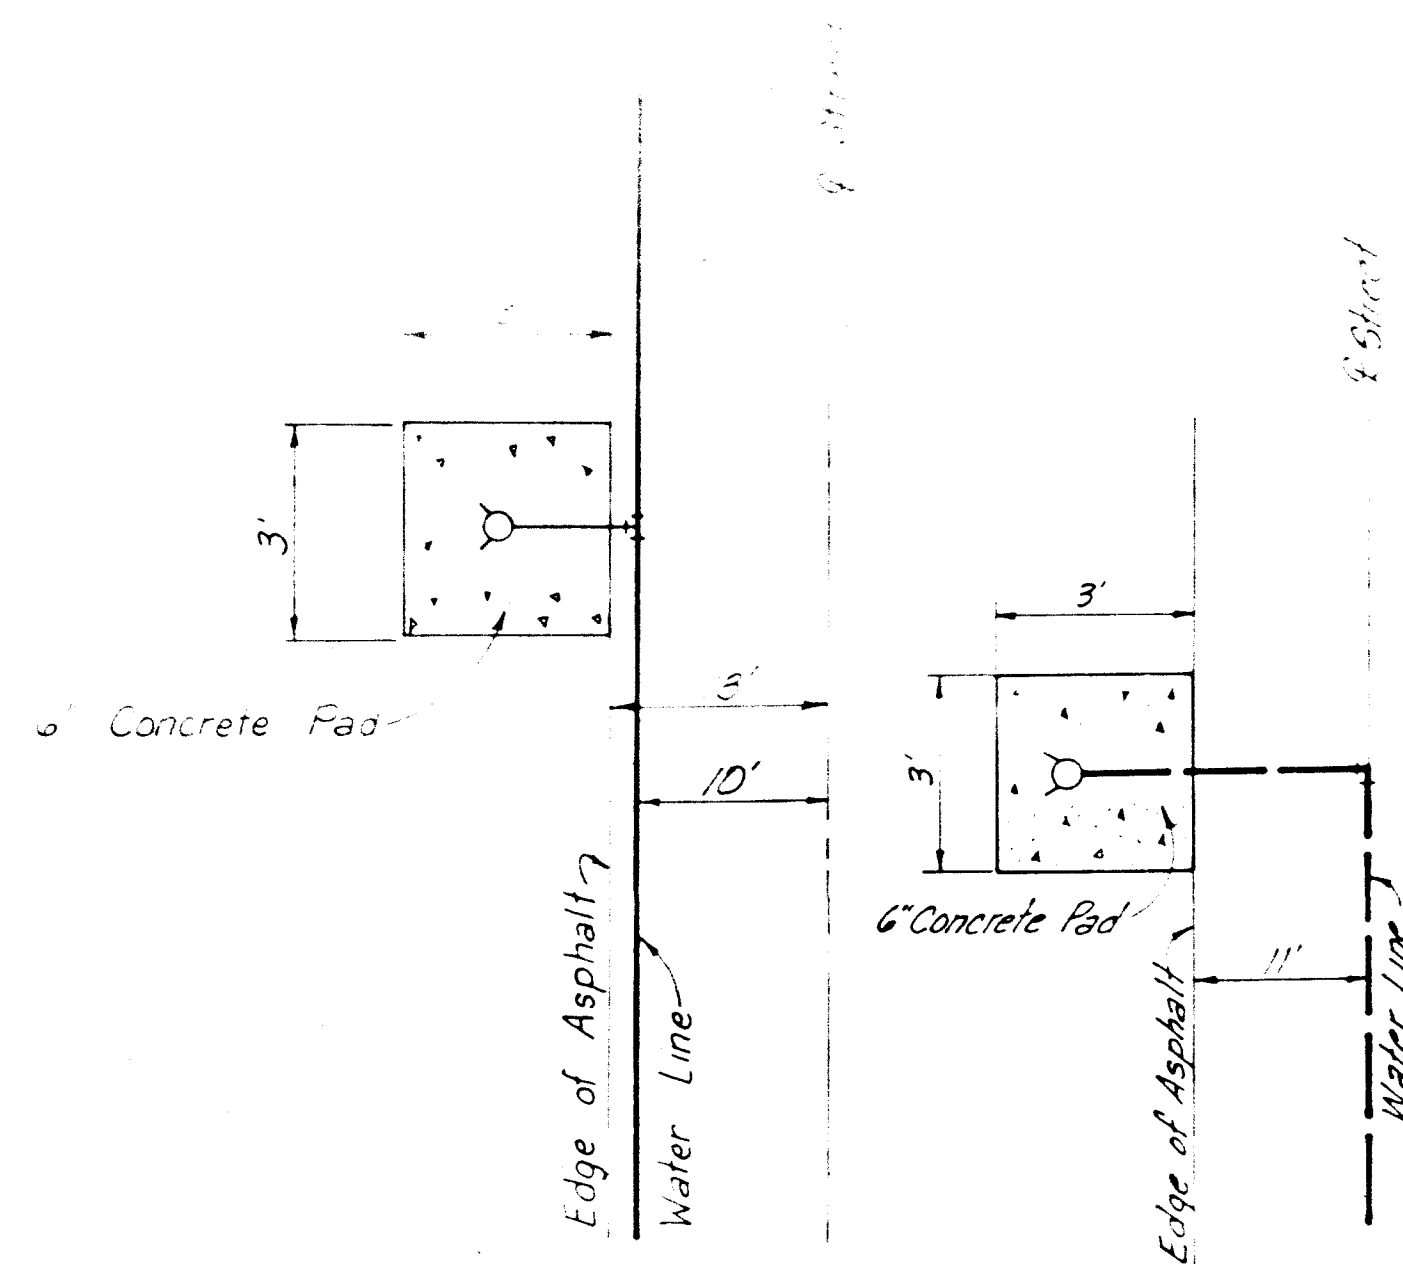


FIRE HYDRANT LOCATION

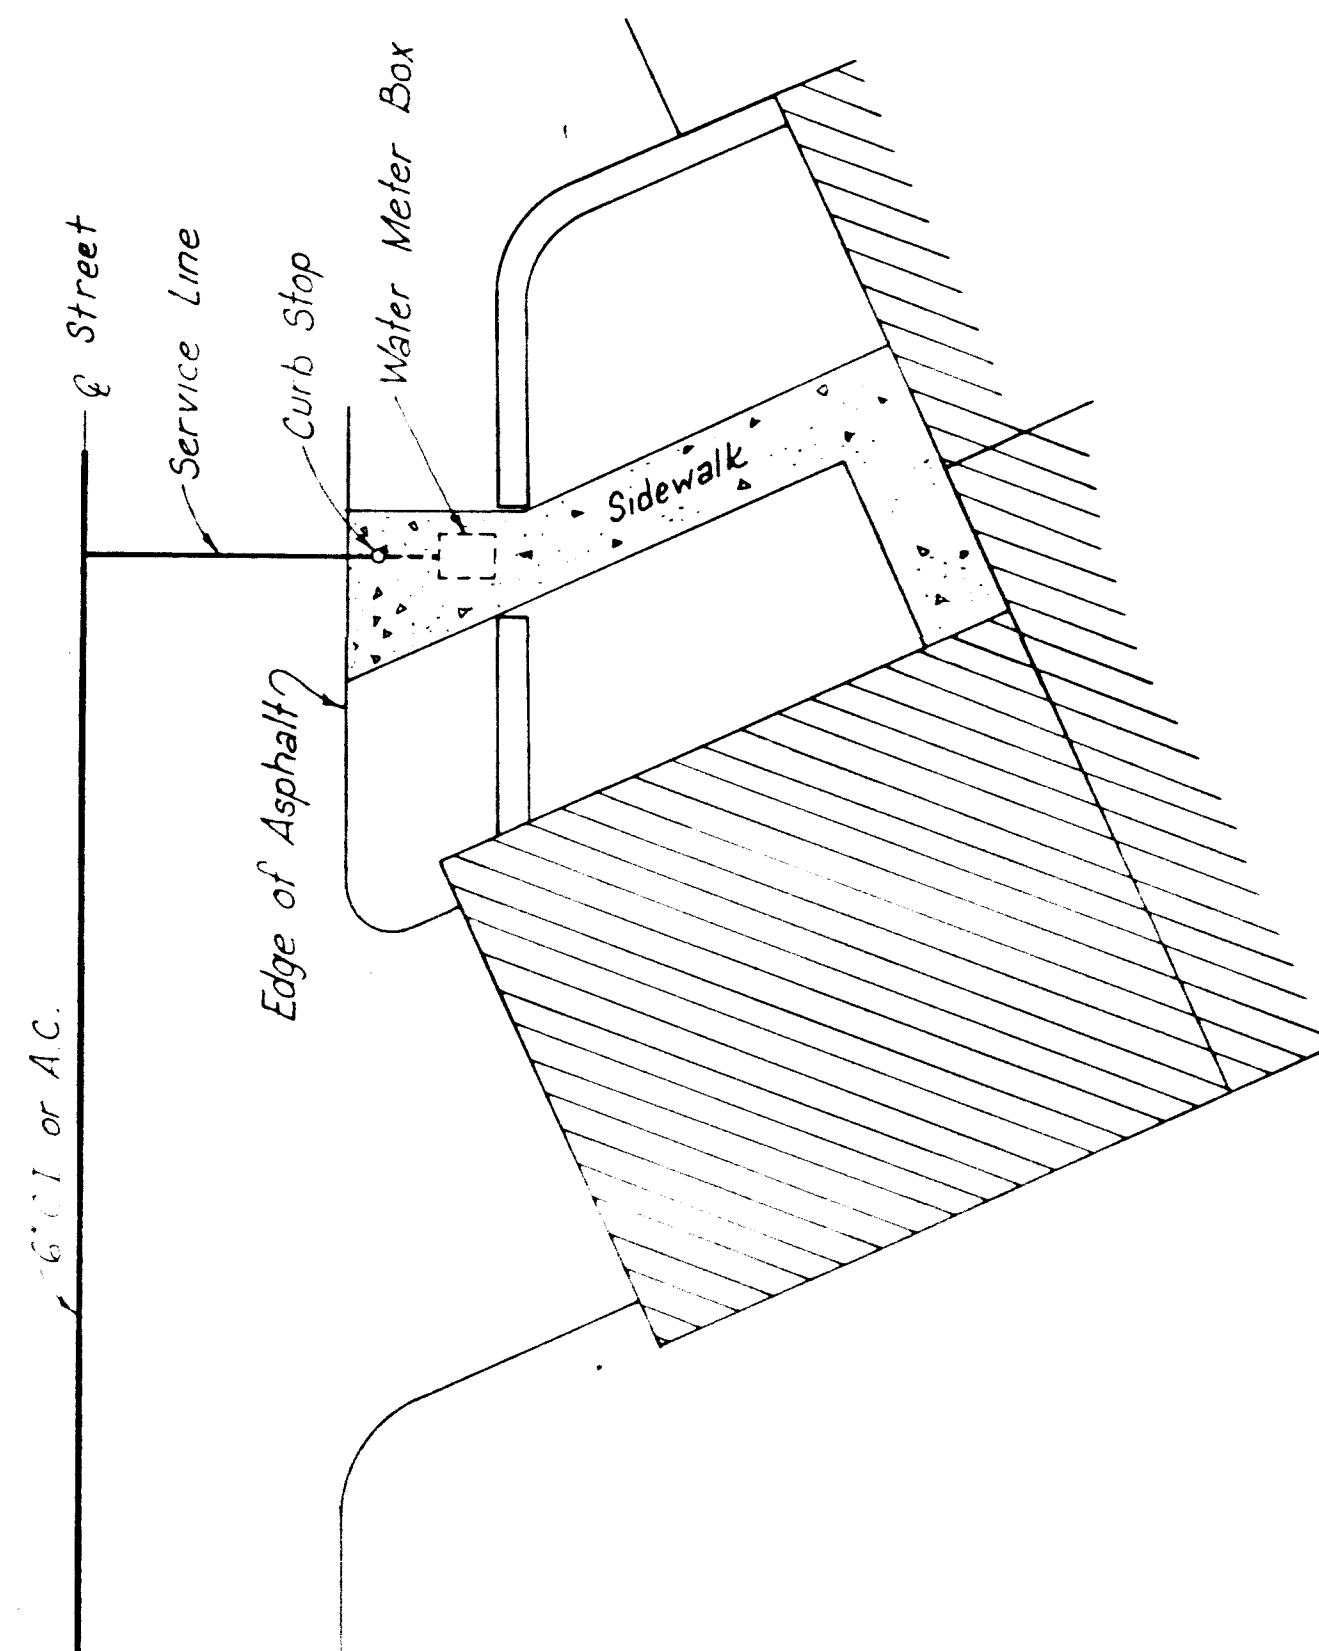


WATER METER BOX LOCATION

CITY OF ALBUQUERQUE
STANDARD WATER DETAILS

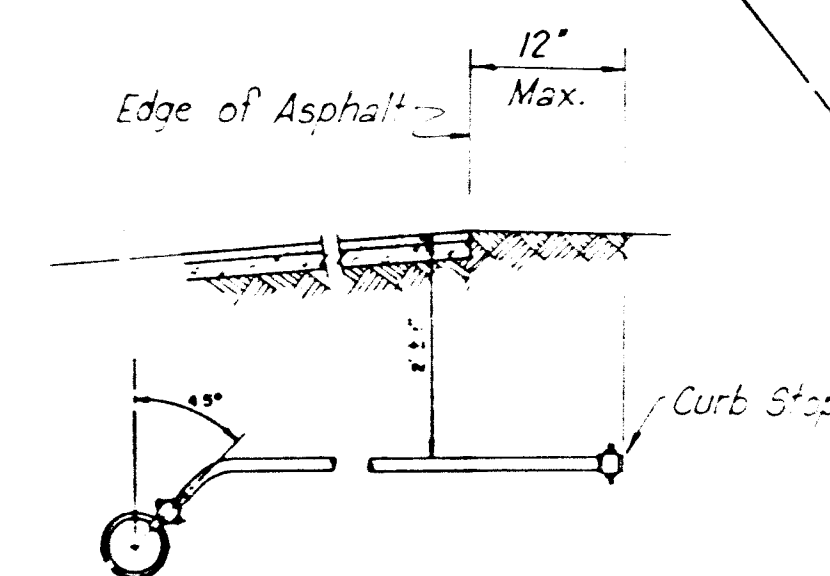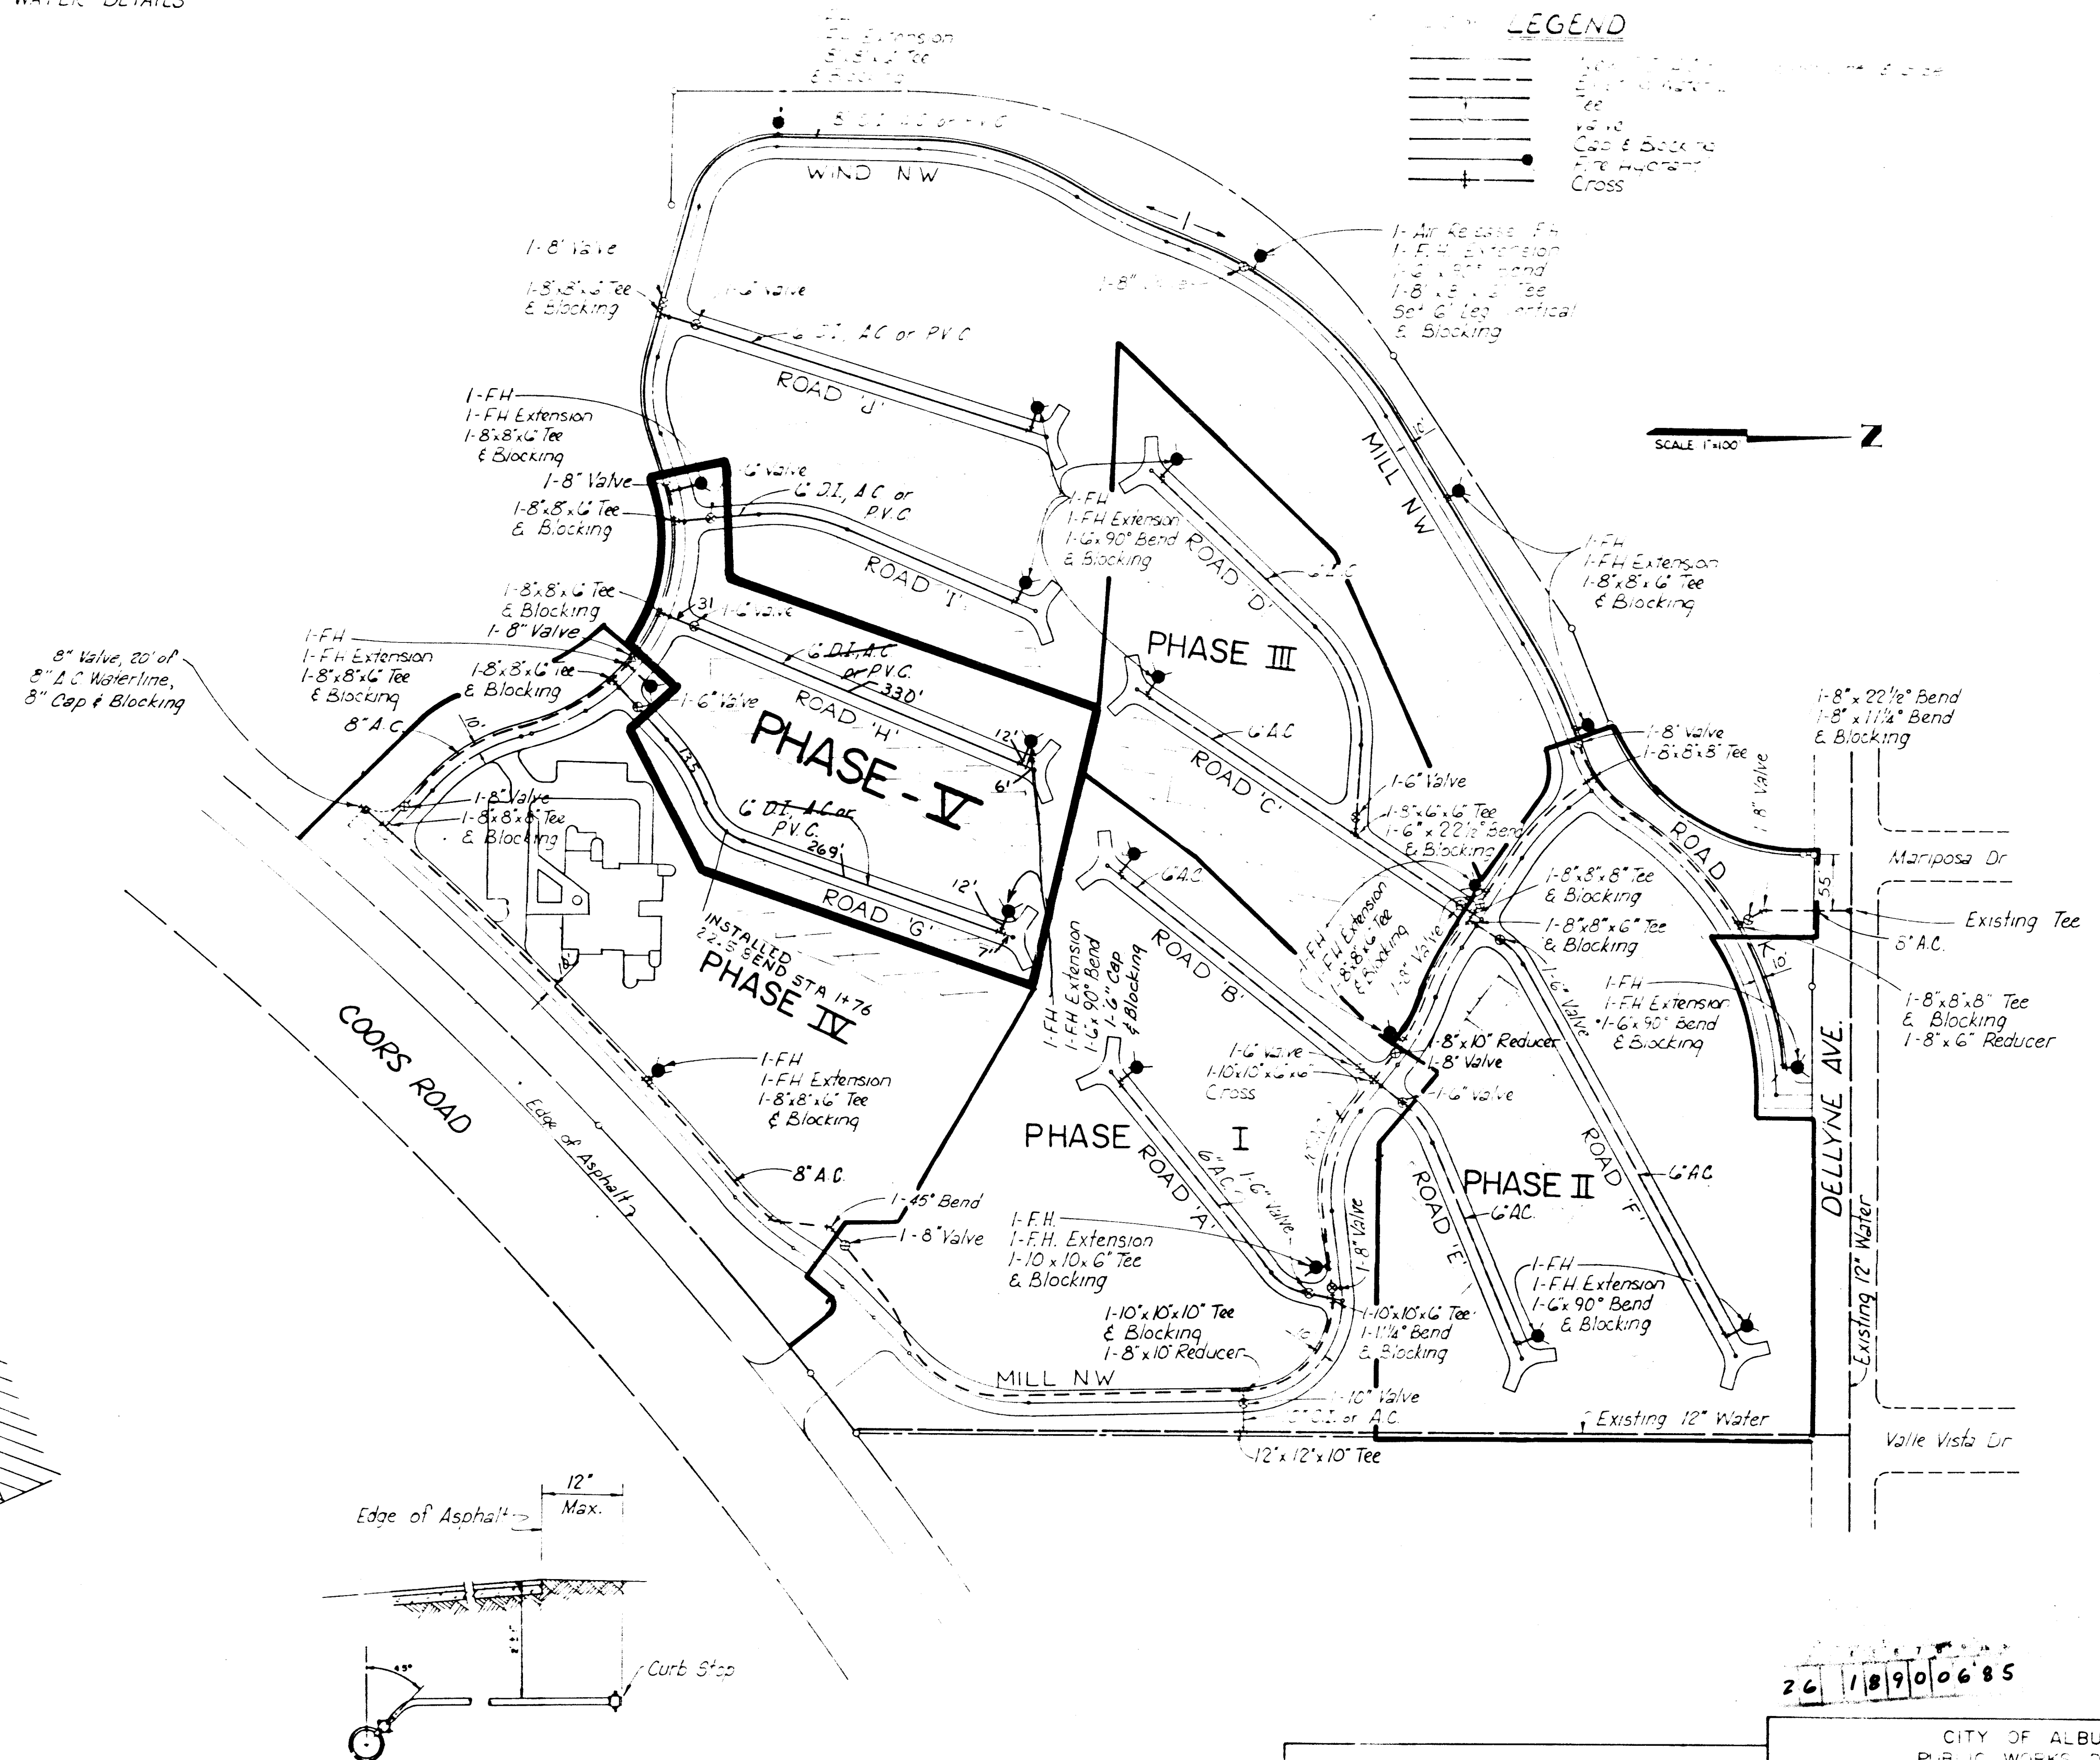

SERVICE LINE DETAIL

LEGEND

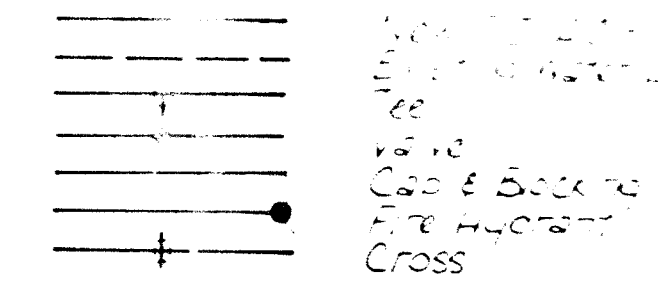


SCALE 1\"/>

REFERENCES				SURVEY INFORMATION				REMARKS			
MAP NO.	EST. NO.	WO. NO.	BY	FIELD NOTES	DATE	NO.	BY	NO.	BY	NO.	BY
F. II											
SIGNATURE				DATE				REVISIONS			
T. T. BURNETT ENGINEERING INC.				120 MORNINGSID DRIVE N.E.				ALBUQUERQUE, NEW MEXICO 87108			
1890				26 18900685							



CITY OF ALBUQUERQUE PUBLIC WORKS DEPARTMENT ENGINEERING DIVISION			
LA LUZ DEL OESTE UNIT 4 WATER LAYOUT PHASE - V			
DESIGNED BY	ENGINEER	DATE	NO.
APPROVED FOR CONSTRUCTION	DATE	NO.	1890
CITY ENGINEER	DATE	NO.	1890
SHEET 6 OF 8		1890	

1890

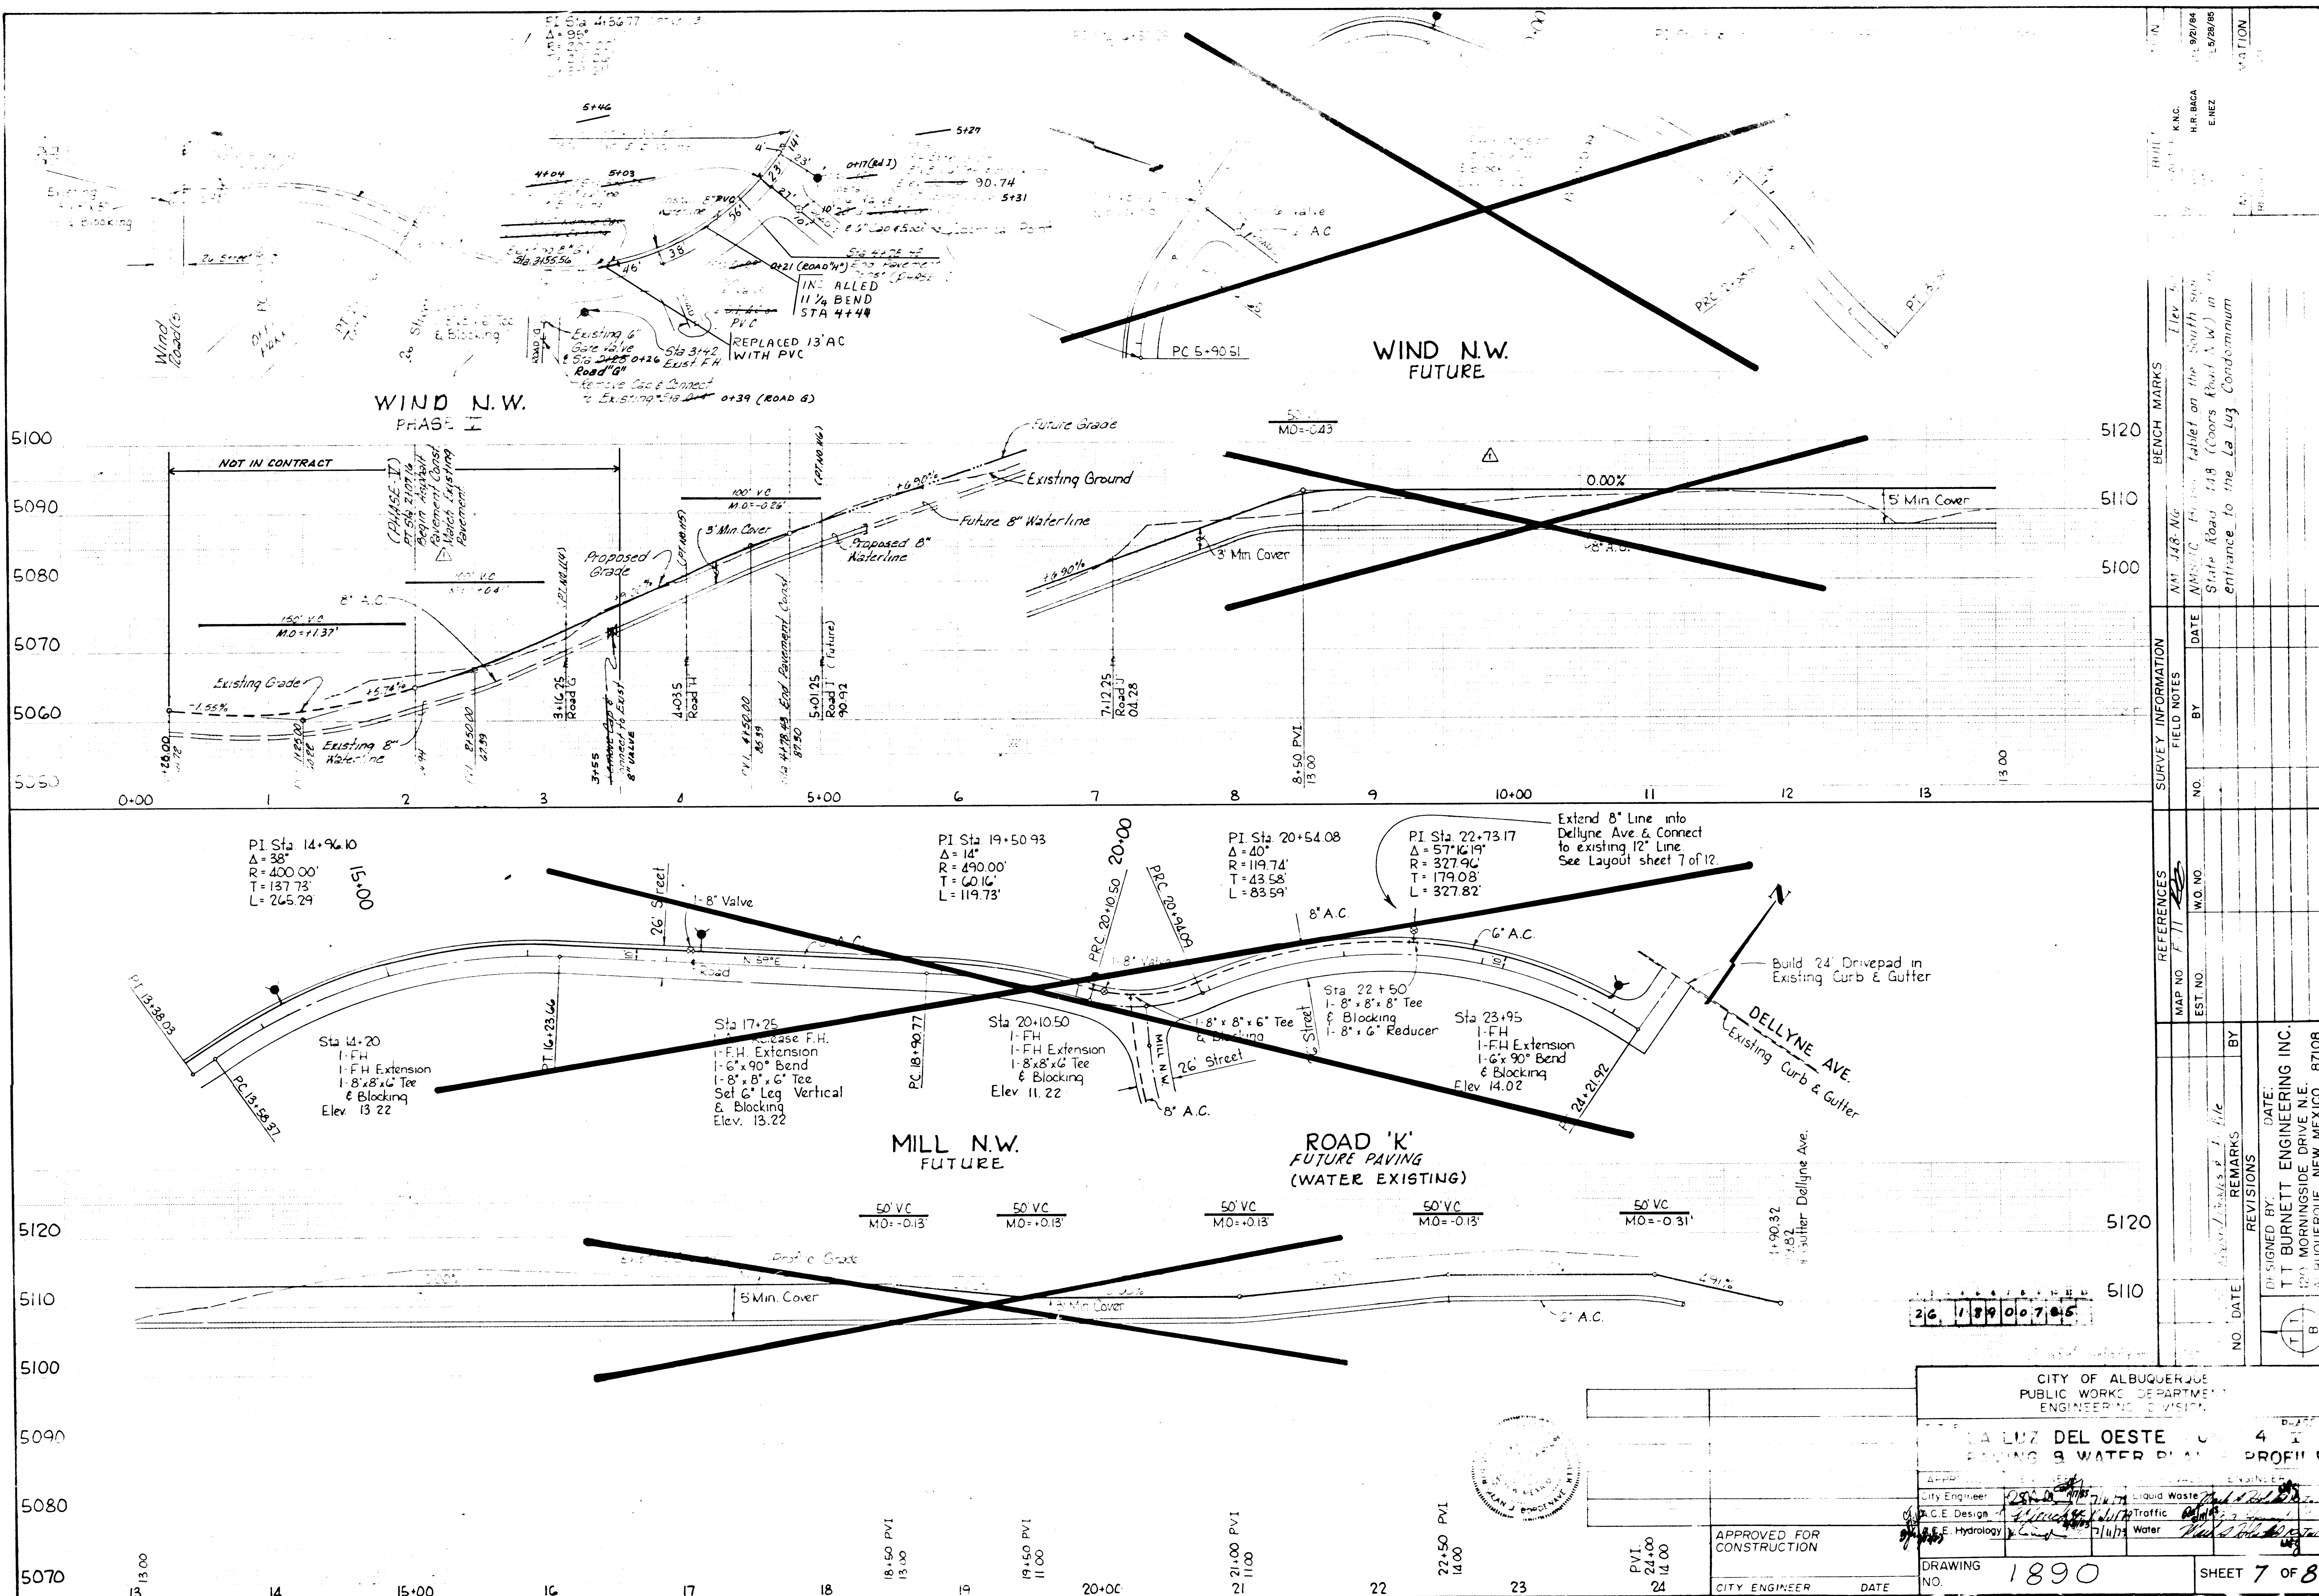

SURVEY INFORMATION				REFERENCES				REVISIONS			
NO.	BY	DATE	ELEV.	MAP NO.	EST. NO.	W.O. NO.	FILE	NO.	DATE	REMARKS	BY
1								1	11/11/75	Initial	
2								2			
3								3			
4								4			
100								100			

CITY OF ALBUQUERQUE PUBLIC WORKS DEPARTMENT ENGINEERING DIVISION	
LA LUZ DEL OESTE 4	
PAVING & WATER PLANS PROFILE	
City Engineer	11/11/75
C.E. Design	11/11/75
C.E. Hydrology	11/11/75
DRAWING NO.	1890
CITY ENGINEER	DATE
SHEET 7 OF 8	

