


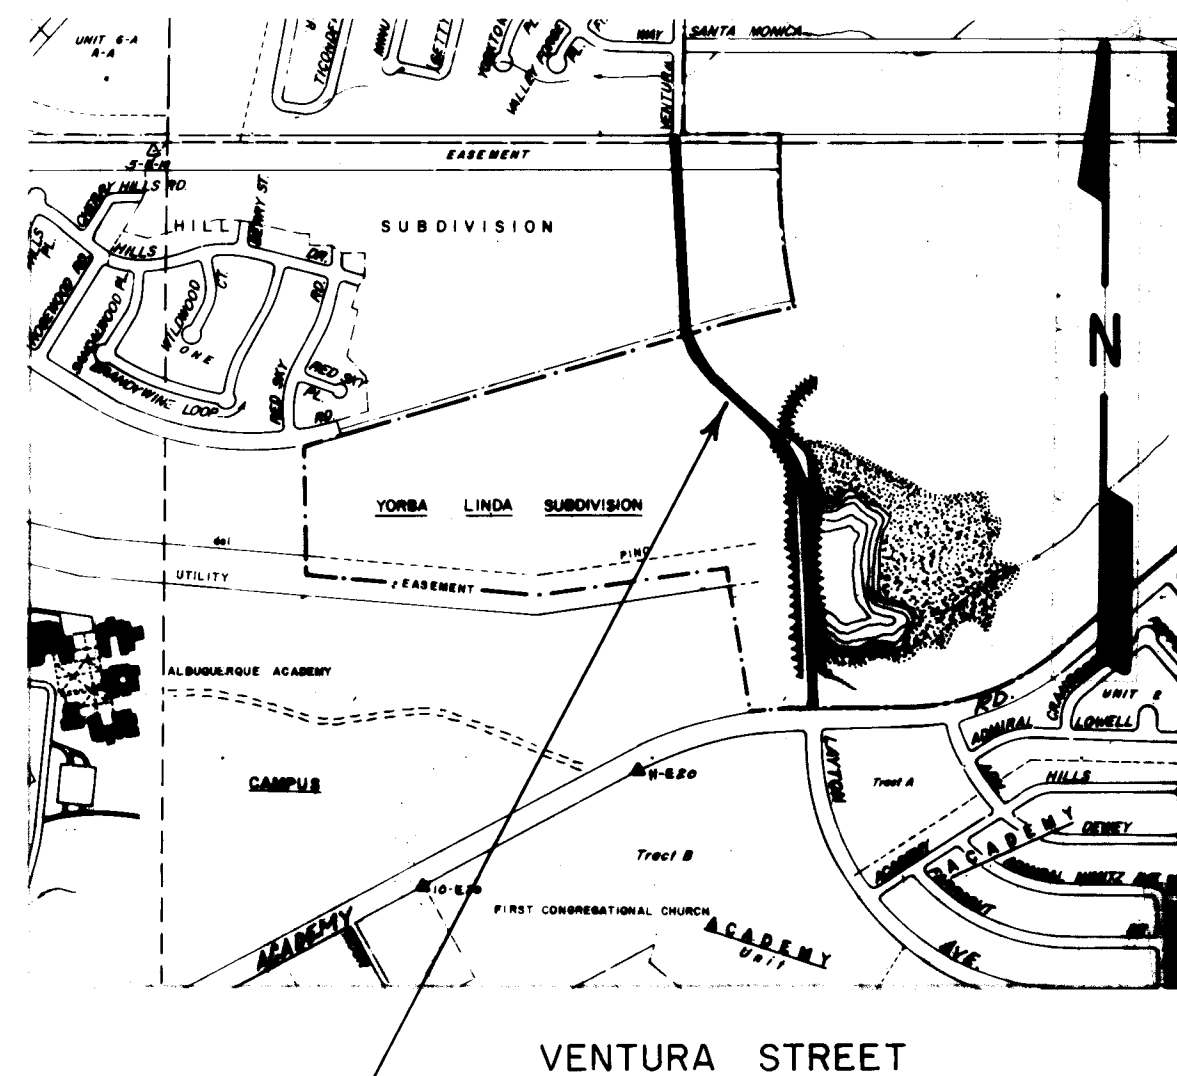

SITE PLAN
SCALE 1" = 1000'


LIST OF DRAWINGS		
SHEET NO.	DRAWING NO.	TITLE
1.		TITLE SHEET
2.		VENTURA STREET
3.		VENTURA STREET
4.		VENTURA STREET

LEGEND

EXISTING		PROPOSED	
— W —	— W —	— W —	WATER LINE
— X —	— X —	— X —	GATE VALVE & BOX
— D —	— D —	— D —	REDUCER
J	J	J	WATER FITTINGS
+	+	+	CAP
+	+	+	CROSS
+	+	+	TEE
— S —	— S —	— S —	SANITARY SEWER LINE
— O —	— O —	— O —	SANITARY SEWER MANHOLE
24" 6' 0" 10' 0" 12' 0" 14' 0" 16' 0" 18' 0" 20' 0" 22' 0" 24' 0" 26' 0" 28' 0" 30' 0" 32' 0" 34' 0" 36' 0" 38' 0" 40' 0" 42' 0" 44' 0" 46' 0" 48' 0" 50' 0" 52' 0" 54' 0" 56' 0" 58' 0" 60' 0" 62' 0" 64' 0" 66' 0" 68' 0" 70' 0" 72' 0" 74' 0" 76' 0" 78' 0" 80' 0" 82' 0" 84' 0" 86' 0" 88' 0" 90' 0" 92' 0" 94' 0" 96' 0" 98' 0" 100' 0"			NOT PART OF THIS PROJECT

ZONE 4E MASTERPLAN WATERMAIN 1984

2000 L.F. 16" DIP
1000 L.F. 14" DIP

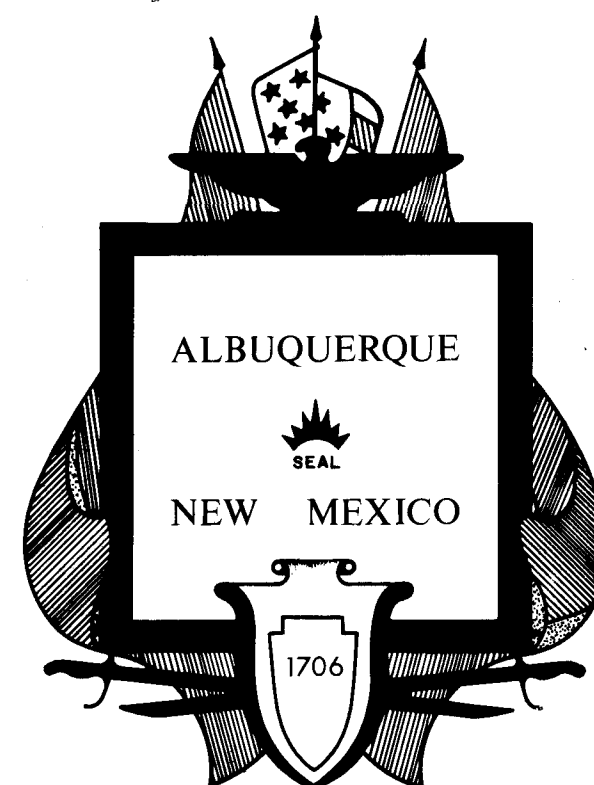

PROJECT ACCEPTED, May. 11, 1984



REV.	SHEETS	CITY	ENGR.	DATE	USER	DEPT.	DATE	USER	DEPT.	DATE
APPROVAL OF REVISIONS										
APPROVED FOR CONSTRUCTION						APPROVED FOR CONSTRUCTION				
W.R.D. CHIEF ENGINEER						CITY ENGINEER				
PROJECT NO. 2060						SHEET 1 OF 4				


GENERAL NOTES

- THE LOCATION OF ALL EXISTING UTILITIES, AS SHOWN ON THE DRAWINGS, ARE APPROXIMATE LOCATIONS. THE CONTRACTOR SHALL BE RESPONSIBLE FOR MAKING FINAL UTILITY LOCATION DETERMINATION IN THE FIELD DURING CONSTRUCTION; THIS IS INCIDENTAL TO CONTRACT.
- THE CONTRACTOR SHALL NOTIFY ALL UTILITY COMPANIES BY CALLING "BLUESTAKES" AT 765-1234 AT LEAST 48 HOURS PRIOR TO COMMENCING WORK IN ANY PART OF THE PROJECT AREA.
- THE CONTRACTOR SHALL BE RESPONSIBLE FOR PROTECTING AND MAINTAINING IN SERVICE ALL EXISTING UTILITIES.
- THE CONTRACTOR SHALL CONFINE HIS WORK TO WITHIN THE CONSTRUCTION LIMITS AND/OR RIGHT-OF-WAYS TO PRESERVE EXISTING VEGETATION AND PRIVATE PROPERTY. OVERNIGHT PARKING OF CONTRACTOR'S EQUIPMENT SHALL NOT OBSTRUCT DRIVEWAY OPENINGS OR DESIGNATED TRAFFIC LANES. THE CONTRACTOR SHALL SCHEDULE HIS TRENCHING INSTALLATION AND BACKFILL OPERATIONS SO THAT ACCESS TO ANY DRIVEWAY IS NOT DISRUPTED LONGER THAN ONE WORKING DAY.
- THE CONTRACTOR SHALL COORDINATE HIS ACTIVITIES WITH THE ENGINEER TO MINIMIZE TRAFFIC DISRUPTIONS. NO CONSTRUCTION WILL BE ALLOWED ADJACENT TO PUBLIC SCHOOLS. EXCEPT DURING SCHOOL HOLIDAYS AND/OR BREAKS.
- A DISPOSAL SITE FOR ALL EXCESS EXCAVATION MATERIALS SHALL BE OBTAINED BY THE CONTRACTOR AND APPROVED BY THE ENGINEER. ALL COSTS INCURRED IN OBTAINING A DISPOSAL SITE, HAULING THERE TO AND PROPER DISPOSAL THEREOF SHALL BE CONSIDERED INCIDENTAL TO CONSTRUCTION AND NOT DIRECT PAYMENT WILL BE MADE THEREFOR.
- THE CITY OF ALBUQUERQUE STANDARD DETAILS ARE INCLUDED IN THE SPECIFICATIONS AND MADE A PART OF THIS CONTRACT.
- THE NEW MEXICO STANDARD SPECIFICATIONS FOR PUBLIC WORKS CONSTRUCTION, 1979 EDITION AND SUPPLEMENTAL SPECIFICATIONS WILL GOVERN WORK ON THIS PROJECT. UNLESS OTHERWISE NOTED IN THE CONTRACT DOCUMENTS.
- WHERE CONCRETE BLOCKING IS CALLED FOR, WRAP ALL BENDS, TEES, AND OTHER FITTINGS WITH POLYETHYLENE.
- WATER SYSTEMS DIVISION SHALL BE THE ONLY AUTHORIZED PERSONNEL TO OPERATE EXISTING VALVES, FIRE HYDRANTS, ETC. ALL WORK SHUTOFFS MUST BE COORDINATED WITH SAID DIVISION THREE (3) FULL WORKING DAYS PRIOR TO PROPOSED SHUTOFFS. CALL 766-7100.
- WATER SYSTEMS DIVISION SHALL HAVE THE AUTHORITY TO CANCEL ALL SCHEDULED SHUTOFFS.
- THE CARE AND PROTECTION OF ALL OTHER UTILITIES, CURB AND GUTTER, SIDEWALK, AND OTHER STREET APPURTENANCES THAT ARE NOT A PART OF THE INTENDED WORK AS SHOWN ON PLANS ARE THE RESPONSIBILITY OF THE CONTRACTOR. IF DAMAGED, LOST IN TRENCH, OR OTHERWISE HARMFULLY DISTURBED, THESE ITEMS WILL BE REPAIRED AT THE CONTRACTOR'S EXPENSE.
- PROPOSED SANITARY SEWER LINE IS NOT PART OF THIS PROJECT.
- CONTRACTOR SHALL BE RESPONSIBLE FOR EXTRA FILL MATERIAL REQUIRED DUE TO SHRINKAGE.
- ALL NEW PIPE IS TO BE HYDROSTATICALLY TESTED FROM VALVE TO VALVE. THE CONTRACTOR SHALL BE RESPONSIBLE FOR ANY EXTRA WORK NECESSARY TO TEST A SECTION OF LINE PRIOR TO CONNECTION TO AN EXISTING VALVE.
- CONTRACTOR TO BE REQUIRED TO POT HOLE CONNECTIONS AND VERIFY FITTINGS PRIOR TO BEGINNING WORK.
- TORQUE ON ALL BOLTS FOR MECHANICAL JOINT FITTINGS MUST BE 75 TO 90 FOOT POUNDS.


CITY OF ALBUQUERQUE

BERNALILLO COUNTY

WATER RESOURCES DEPARTMENT

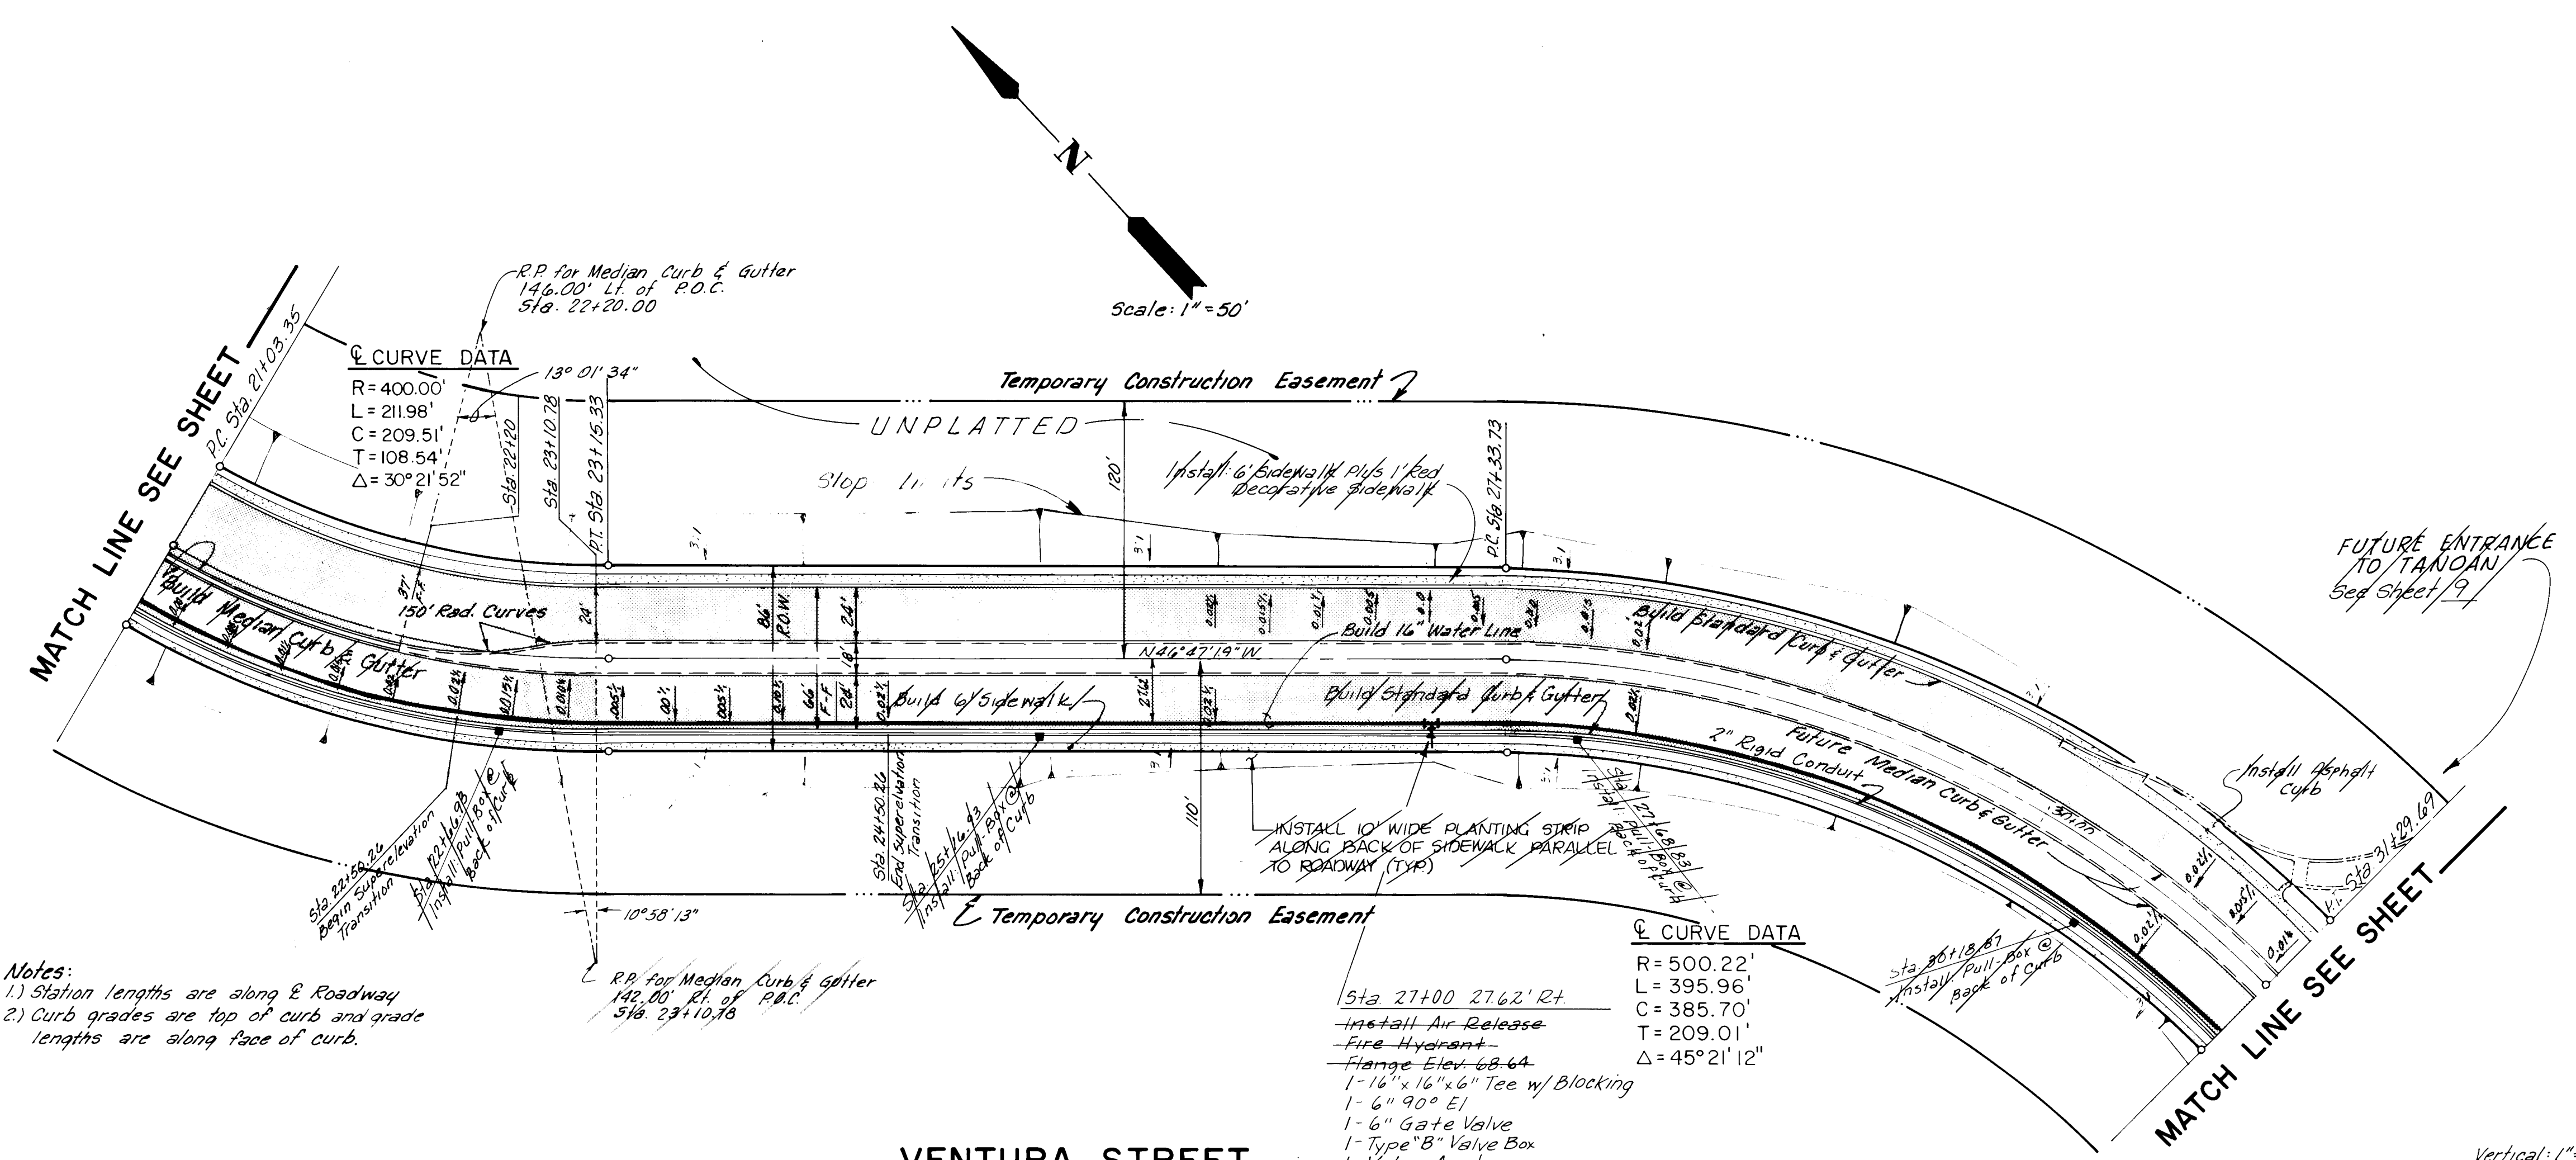

Notes:
1) Station lengths are along S. Roadway
2) Curb grades are top of curb and grade lengths are along face of curb.

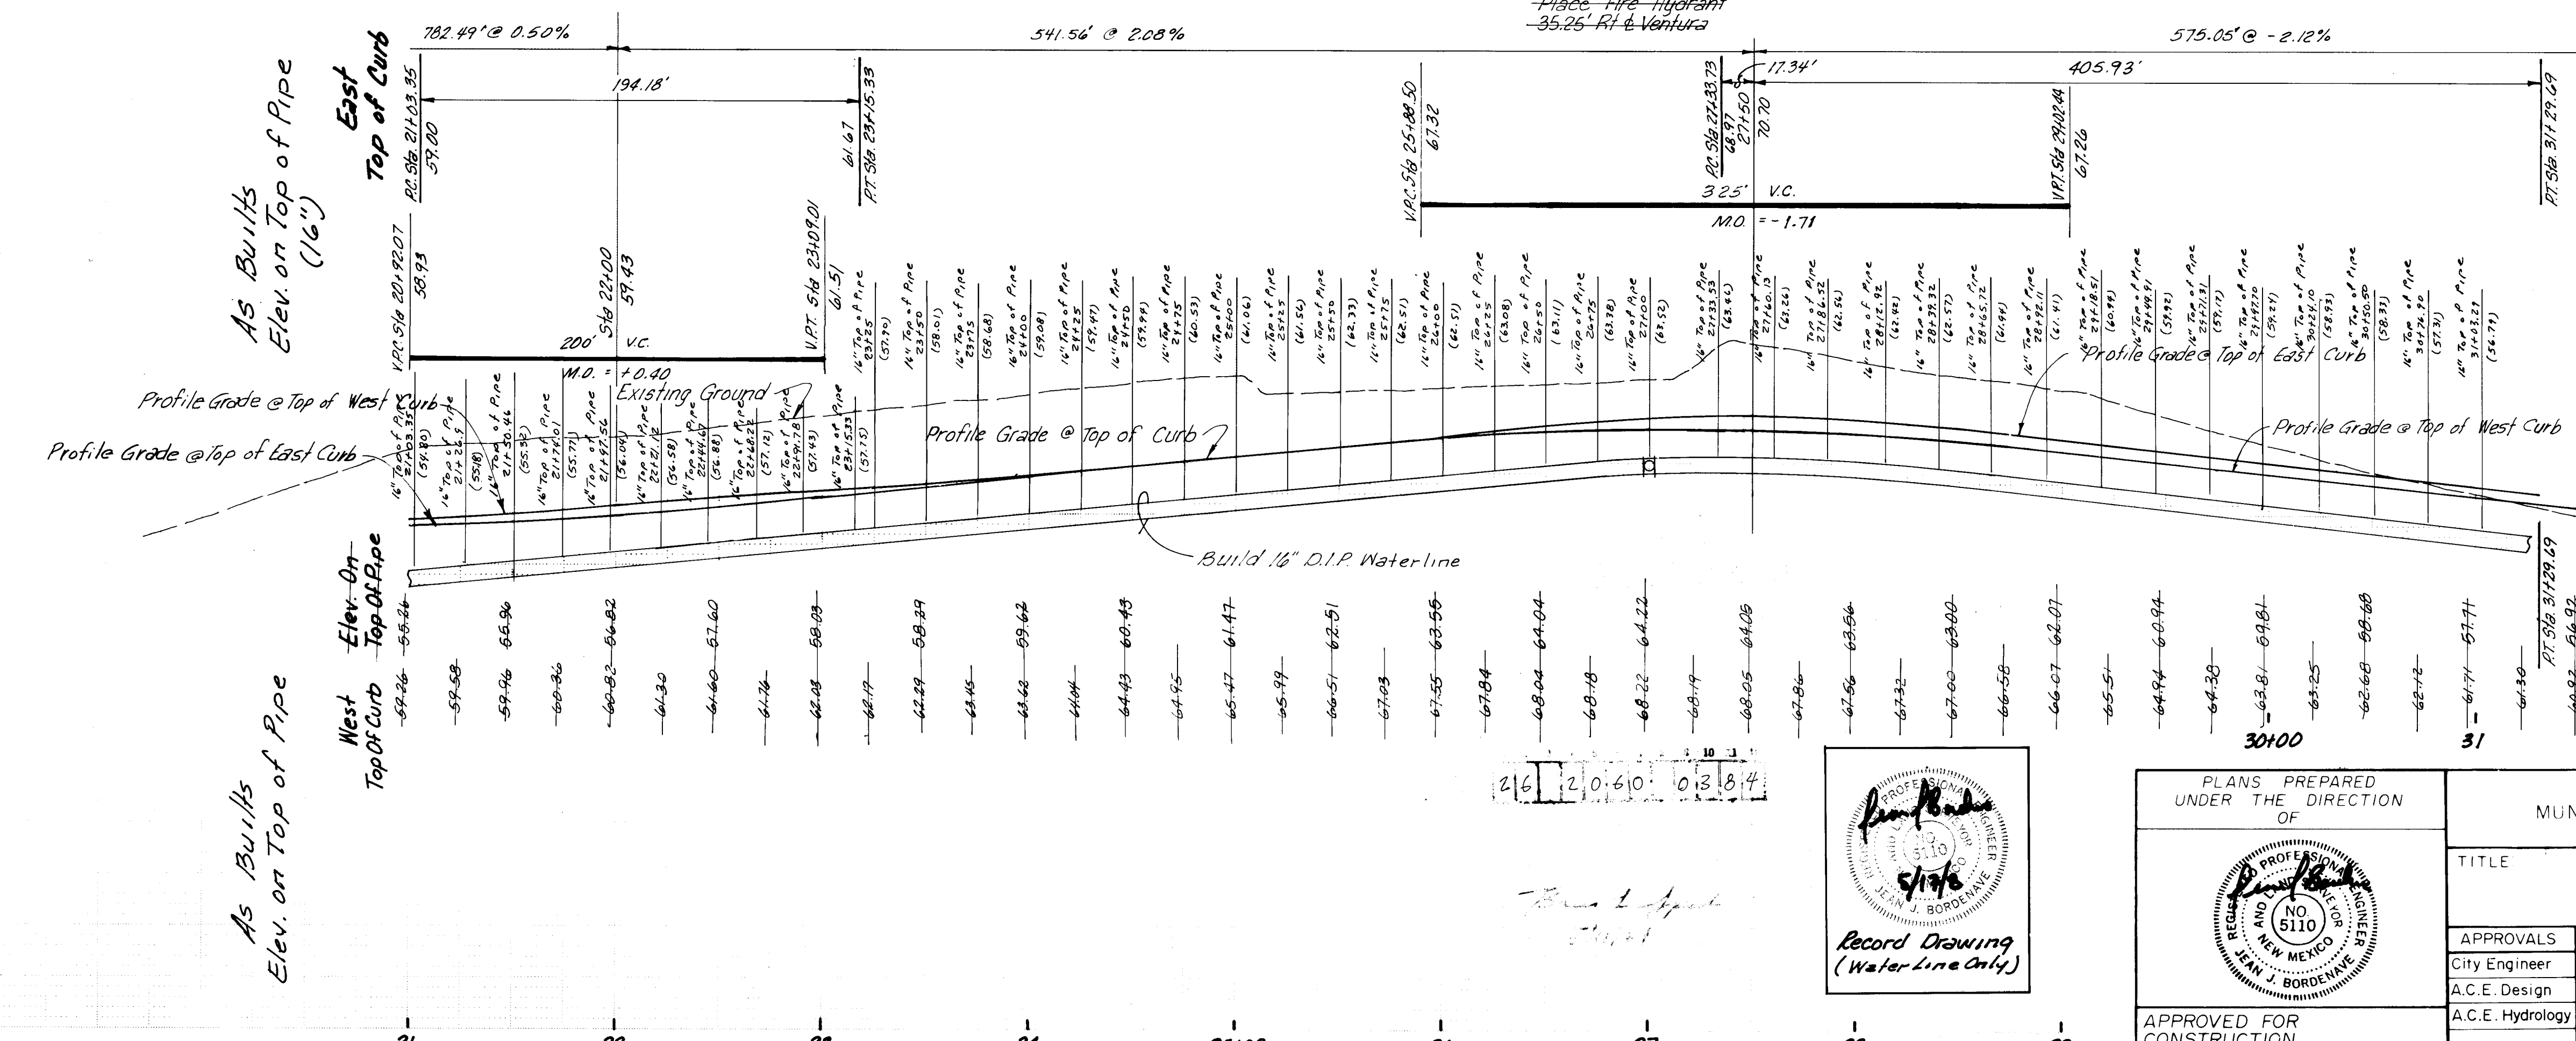

PLANS PREPARED UNDER THE DIRECTION OF		CITY OF ALBUQUERQUE MUNICIPAL DEVELOPMENT DEPARTMENT ENGINEERING DIVISION	
TITLE VENTURA STREET WATERLINE STA. 21+00 TO STA. 32+00			
APPROVALS	ENGINEER	DATE	APPROVALS
City Engineer	2/1/2000	2/1/2000	2/1/2000
A.C.E. Design			
A.C.E. Hydrology			
DRAWING NO. 2060		SHEET 3 OF 4	

