


ALBUQUERQUE, NEW MEXICO

INDEX TO SHEETS

SHEET NO.	DESCRIPTION
1	COVER SHEET AND INDEX TO DRAWINGS
2	PLAT OF GEOMETRY
3-4	STREET PLAN AND PROFILE
5	COMPOSITE UTILITY PLAN
6-11	UTILITY PLAN AND PROFILES
12	STORM SEWER PLAN & PROFILE & DETAILS

RECORD DRAWING

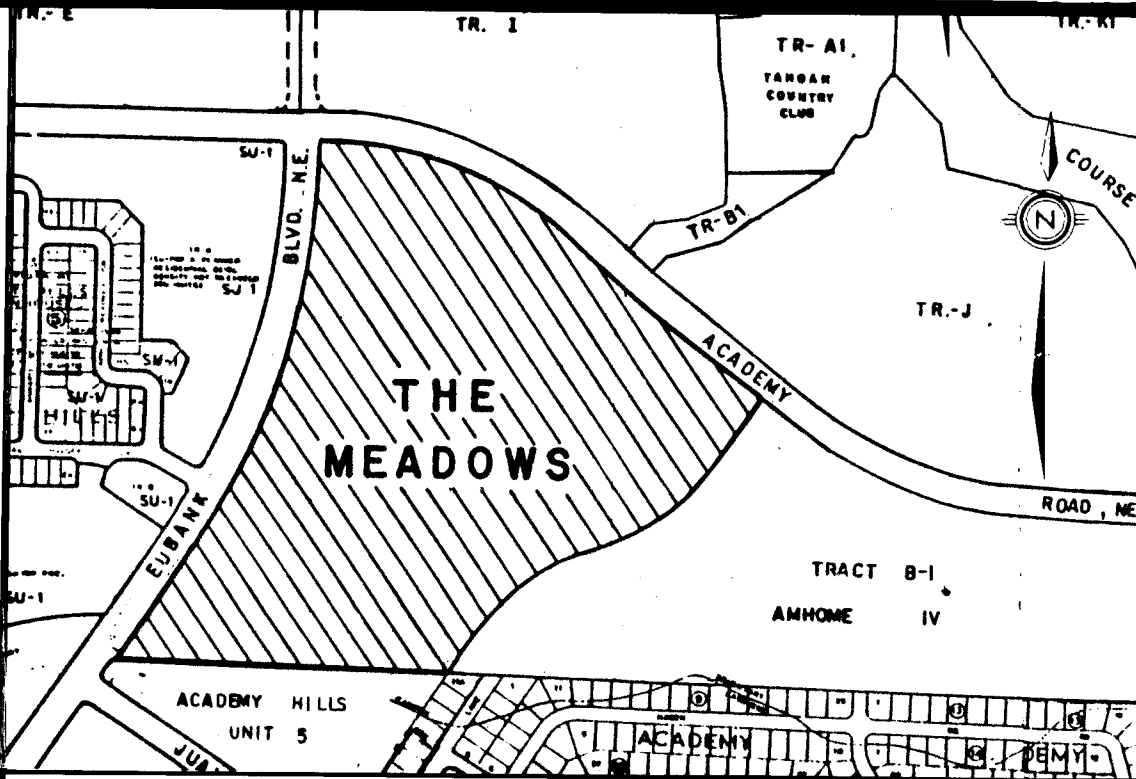

LOCATION MAP
SCALE: 1" = 800' (approx.)

GENERAL NOTES:

1. All work detailed on these plans to be performed under contract shall, except as otherwise stated or provided for herein, be constructed in accordance with the New Mexico Standard Specifications for Public Works Construction - 1979 Edition (referred to herein as the Standard Specifications and the Contract Documents for Public Works Contract #84-1.
2. Two (2) working days prior to any excavation, contractor must contact Line Locating Service, 765-1234, for location of existing utilities.
3. Prior to construction, the contractor shall excavate and verify the horizontal and vertical locations of all obstructions. Should a conflict exist, the contractor shall notify the engineer or surveyor so that the conflict can be resolved with minimum amount of delay.
4. All utilities and utility service lines shall be installed prior to paving.
5. Backfill compaction shall be according to specified street use.
6. Tack coat requirements shall be determined by the City Engineer.
7. Sidewalks and wheelchair ramps within the curb returns shall be constructed wherever a new curb return is constructed.
8. If curb is depressed for a driveway or a handicap ramp, the driveway or ramp shall be constructed prior to acceptance of the curb and gutter.
9. All storm drainage facilities shall be completed prior to final acceptance.


RECORD DRAWING

APPROVAL OF AS BUILT DRAWINGS
 10. F. McNamee / HEO
 12-5-84

26 2155 0184

Δ	5, 10, 11							
Δ	6, 12	<i>ad. approved</i>	<i>9/1/84 Hydrology - B. B. Archibald</i>	<i>8/30/84</i>				
REV	SHEETS	CITY ENGINEER	DATE	USER	DEPARTMENT	DATE	USER	DEPARTMENT
APPROVAL OF REVISIONS								

ENGINEERS SEAL		DATE: _____ SCALE: _____ DESIGNED: _____ DRAWN: _____ JOB NO: _____		APPROVED FOR CONSTRUCTION  CITY ENGINEER 7/24/84 DATE	
 6/24/84		PROJECT NO. 2155		SHEET 1 OF 12	

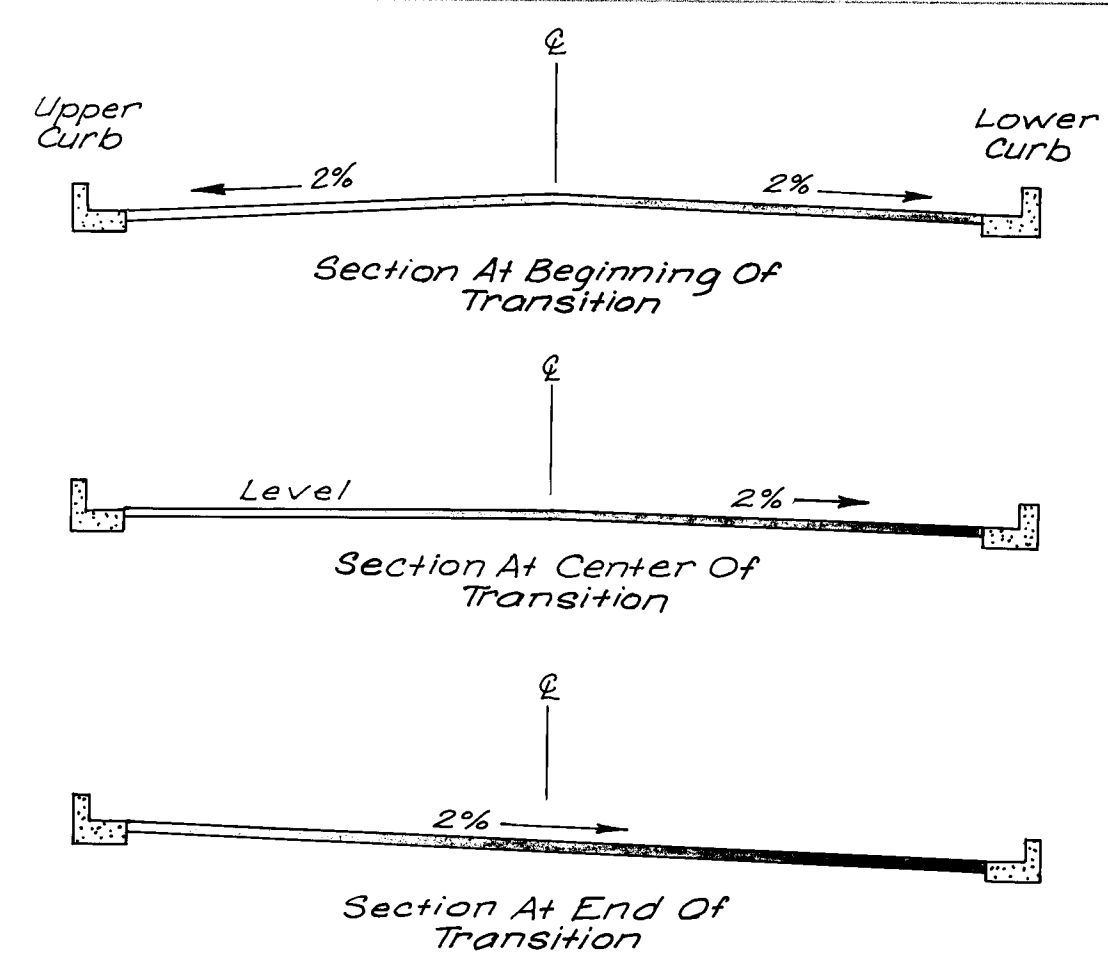


TRANSITION: CROWN TO SUPERELEVATION
N.T.S.

TRACT A

TRACT B

ROLLING HILLS DRIVE, N.E.
(RESIDENTIAL PAVEMENT)

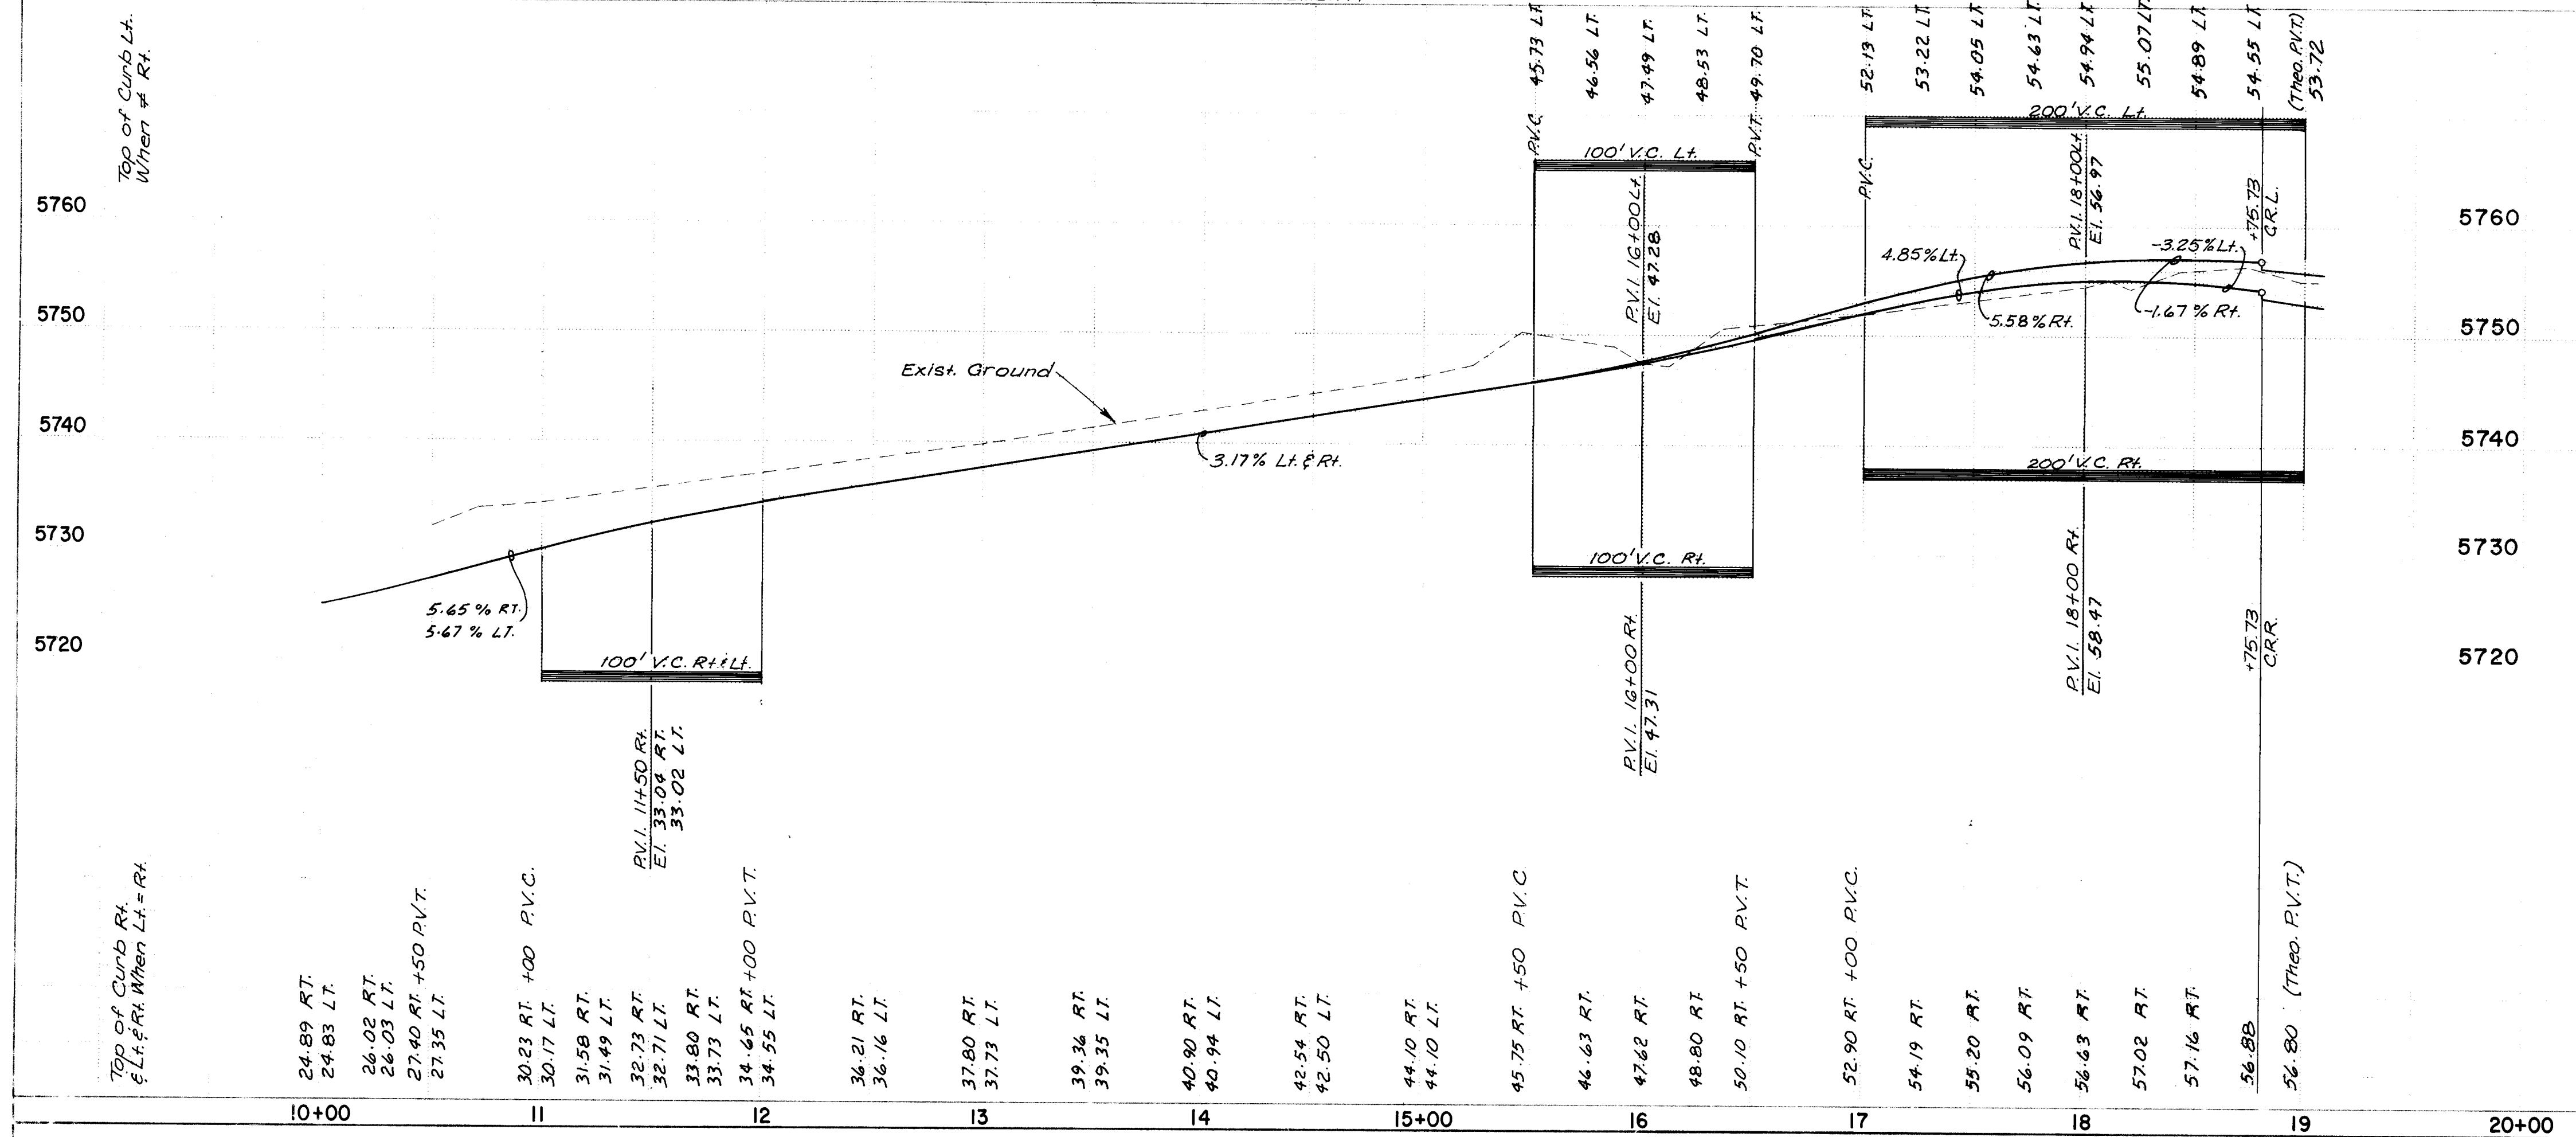


Q POINTS
TC 52.60 F.L. 51.96
TC 53.36 F.L. 52.69
TC 54.10 F.L. 53.45

Q Curve Data
R = 1000.00'
Δ = 18°18'09"
A = 318.86'

Q POINTS
T.C. 56.94 F.L. 56.22
T.C. 57.22 F.L. 56.55
T.C. 57.41 F.L. 56.77

RECORD DRAWING
I, Claude A.L. Pilley, N.M.P.E. & I.S. No. 4981,
hereby certify that this drawing has been
revised in accordance with information furnished
by K.N.C. Inc. Field surveys and that both the
revisions and field surveys were done under
my personal direction and control.

Claude A.L. Pilley
CLAUDE A.L. PILLEY

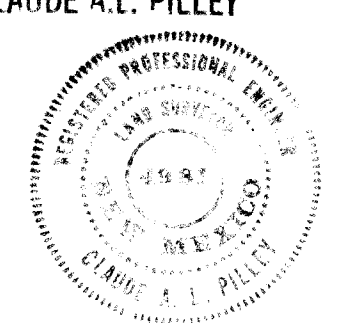

SCALE: 1" = 50' Horizontal
1" = 10' Vertical


CITY OF ALBUQUERQUE MUNICIPAL DEVELOPMENT DEPARTMENT ENGINEERING DIVISION			
TITLE THE MEADOWS - PAVING PLAN AND PROFILE ROLLING HILLS DRIVE, N.E.			
APPROVALS	ENGINEER	DATE	APPROVALS
City Engineer	<i>C. J. Pilley</i>	7/1/84	City Engineer
A.C.E. Design	<i>R. J. Pilley</i>	7/1/84	A.C.E. Design
A.C.E. Hydrology	<i>R. J. Pilley</i>	7/1/84	A.C.E. Hydrology
DRAWING NO 2155		MAP NO E-21	
SHEET 4		OF 12	

BENCH MARKS
KNC Inc.
M. Pohl
10-184

ACS BRASS CAP "3-E21A 1977" LOCATED WEST OF THE TANOH COUNTRY CLUBHOUSE AND APPROXIMATELY 1000' NORTH OF THE INTERSECTION OF SEVILLE DRIVE N.E. AND ACADEMY ROAD N.E. ELEV. = 5765.23

ENGINEER'S SEAL
CLAUDE A.L. PILLEY
REGISTERED PROFESSIONAL ENGINEER
STATE OF NEW MEXICO
NO. 4981

REVISIONS
BY DATE
M.P. 10-17-84
Revised To Show As-Built
REMARKS
42 DIVISIONS
DESIGN
DATE JUNE, 1984
DATE JUNE, 1984

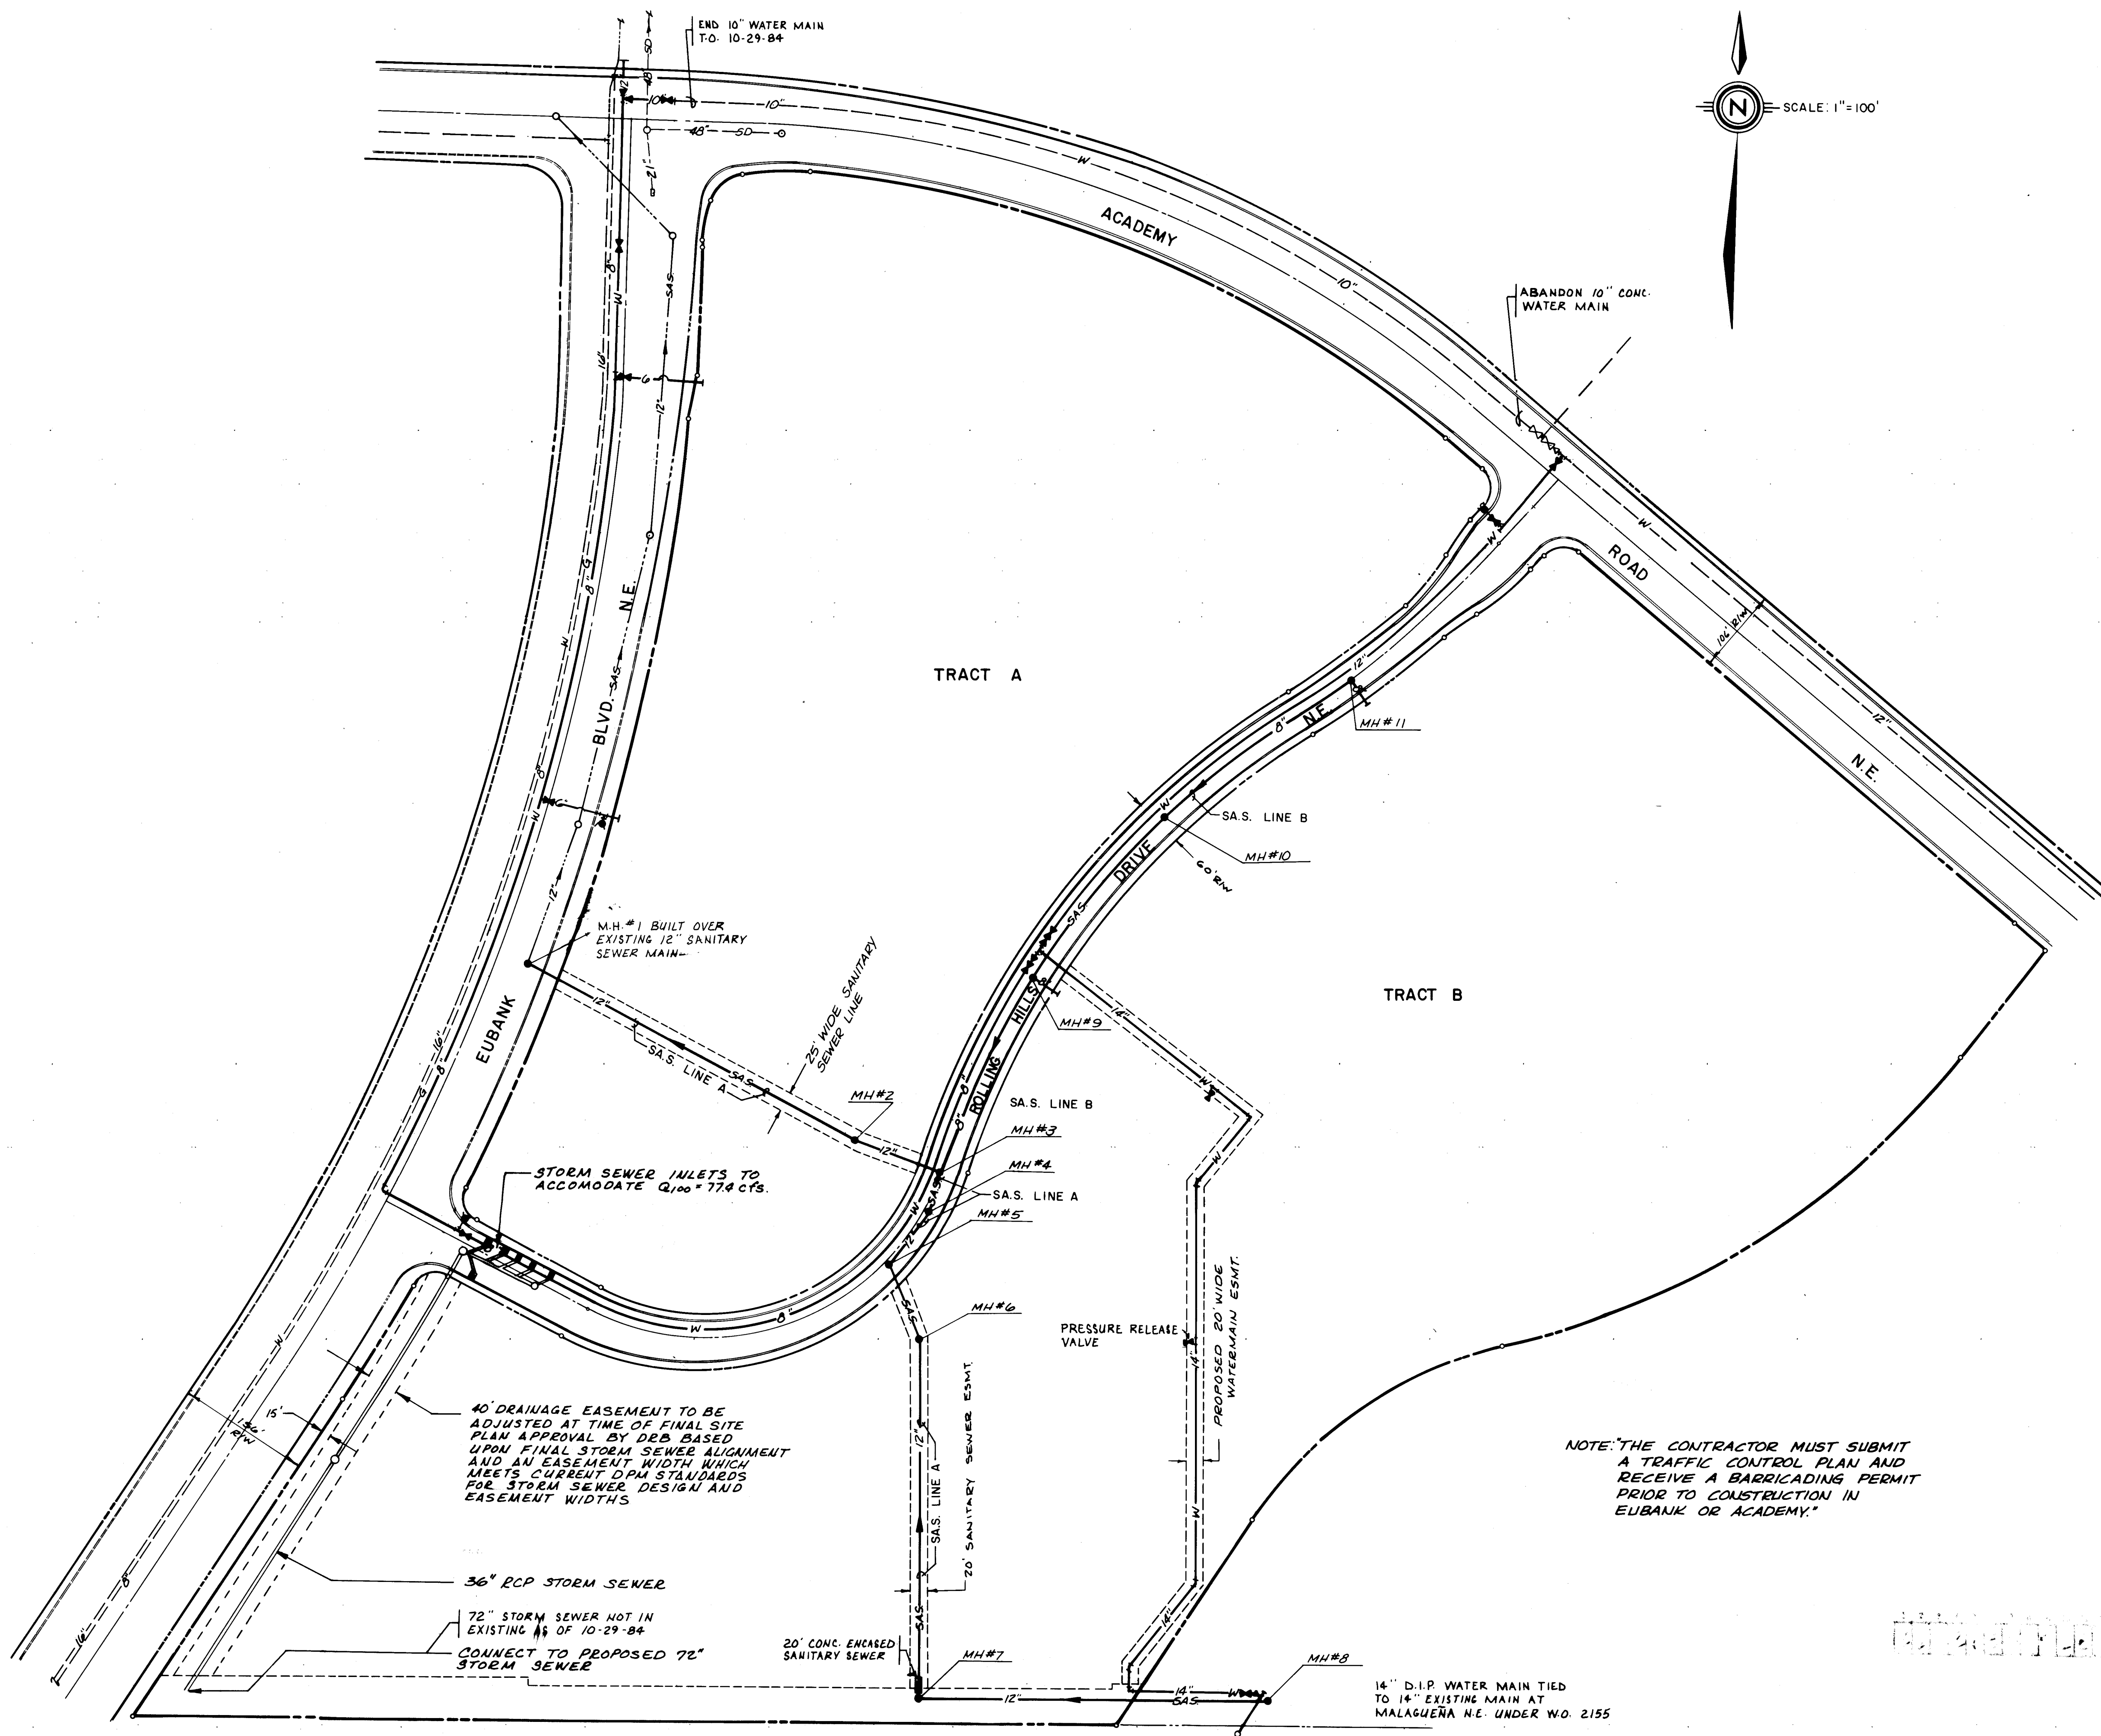

GENERAL UTILITY NOTES:

- 1) The Contractor shall furnish ELDs on all Water & Sewer service stubs, caps and plugs.
- 2) All stationing refers to street centerline unless noted otherwise.
- 3) Contractor shall field verify locations and elevations of all existing pipe & utilities prior to construction.
- 4) All tees, bends and caps shall be blocked according to City of Albuquerque Standards.
- 5) All pipe shall be furnished with class "C" bedding unless otherwise noted.
- 6) Where gate valves and hydrants are shown at intersections, these shall be located opposite curb return indicated.
- 7) All trench backfill shall be compacted to a minimum of 90% of optimum (Modified).
- 8) Pipe Specifications:
 8" WM - Class 150 AWWA C900
 14" WM - Class 2 DIP
 12" San Sewer - SDR-35
- 9) All Watermain Fittings shall be cast iron, push-on bell tight or MJ.

LEGEND

- EXIST. SANITARY SEWER — SAS —
- EXIST. WATER — W —
- EXIST. GAS — G —
- PROPOSED SANITARY SEWER — SAS —
- PROPOSED WATER — W —
- FUTURE SANITARY SEWER — SAS —
- FUTURE STORM DRAIN — SD —
- EXIST. MANHOLE — ○ —
- PROPOSED MANHOLE — ○ —
- EXIST. VALVE — X —
- PROPOSED VALVE — X —
- EXIST. REDUCER — Δ —
- PROPOSED REDUCER — Δ —
- TEE — + —
- BEND — ∟ —
- CAP AND PLUG — ⊕ —

NOTE: THE CONTRACTOR MUST SUBMIT A TRAFFIC CONTROL PLAN AND RECEIVE A BARRICADING PERMIT PRIOR TO CONSTRUCTION IN EUBANK OR ACADEMY.

AS BUILT INFORMATION		BENCH MARKS		SURVEY INFORMATION		ENGINEER'S SEAL	
CONTRACTOR	DATE	NO.	BY	NO.	BY	DATE	REMARKS
INSPECTOR'S	DATE	DATE	DATE	DATE	DATE	DATE	DESIGN
FIELD CHECKED BY	DATE	DATE	DATE	DATE	DATE	DATE	REVISIONS
VERIFICATION BY	DATE	DATE	DATE	DATE	DATE	DATE	DESIGN
CORRECTED BY	DATE	DATE	DATE	DATE	DATE	DATE	REVISIONS
RECORDED BY	DATE	DATE	DATE	DATE	DATE	DATE	DESIGN
NO.	DATE	DATE	DATE	DATE	DATE	DATE	REVISIONS

26 21 35 05 84


**CITY OF ALBUQUERQUE
MUNICIPAL DEVELOPMENT DEPARTMENT
ENGINEERING DIVISION**

TITLE: THE MEADOWS


UTILITY COMPOSITE PLAN

APPROVALS	ENGINEER	DATE	APPROVALS	ENGINEER	DATE
City Engineer	<i>[Signature]</i>	7/1/84	Liquid Waste	<i>[Signature]</i>	7-9-84
A C E - Design	<i>[Signature]</i>	7/1/84	Traffic	<i>[Signature]</i>	7/1/84
A C E - Hydrology	<i>[Signature]</i>	7/1/84	Water Resources	<i>[Signature]</i>	7-9-84


DRAWING NO. **2155** MAP NO. **E-21** SHEET **5** OF **12**

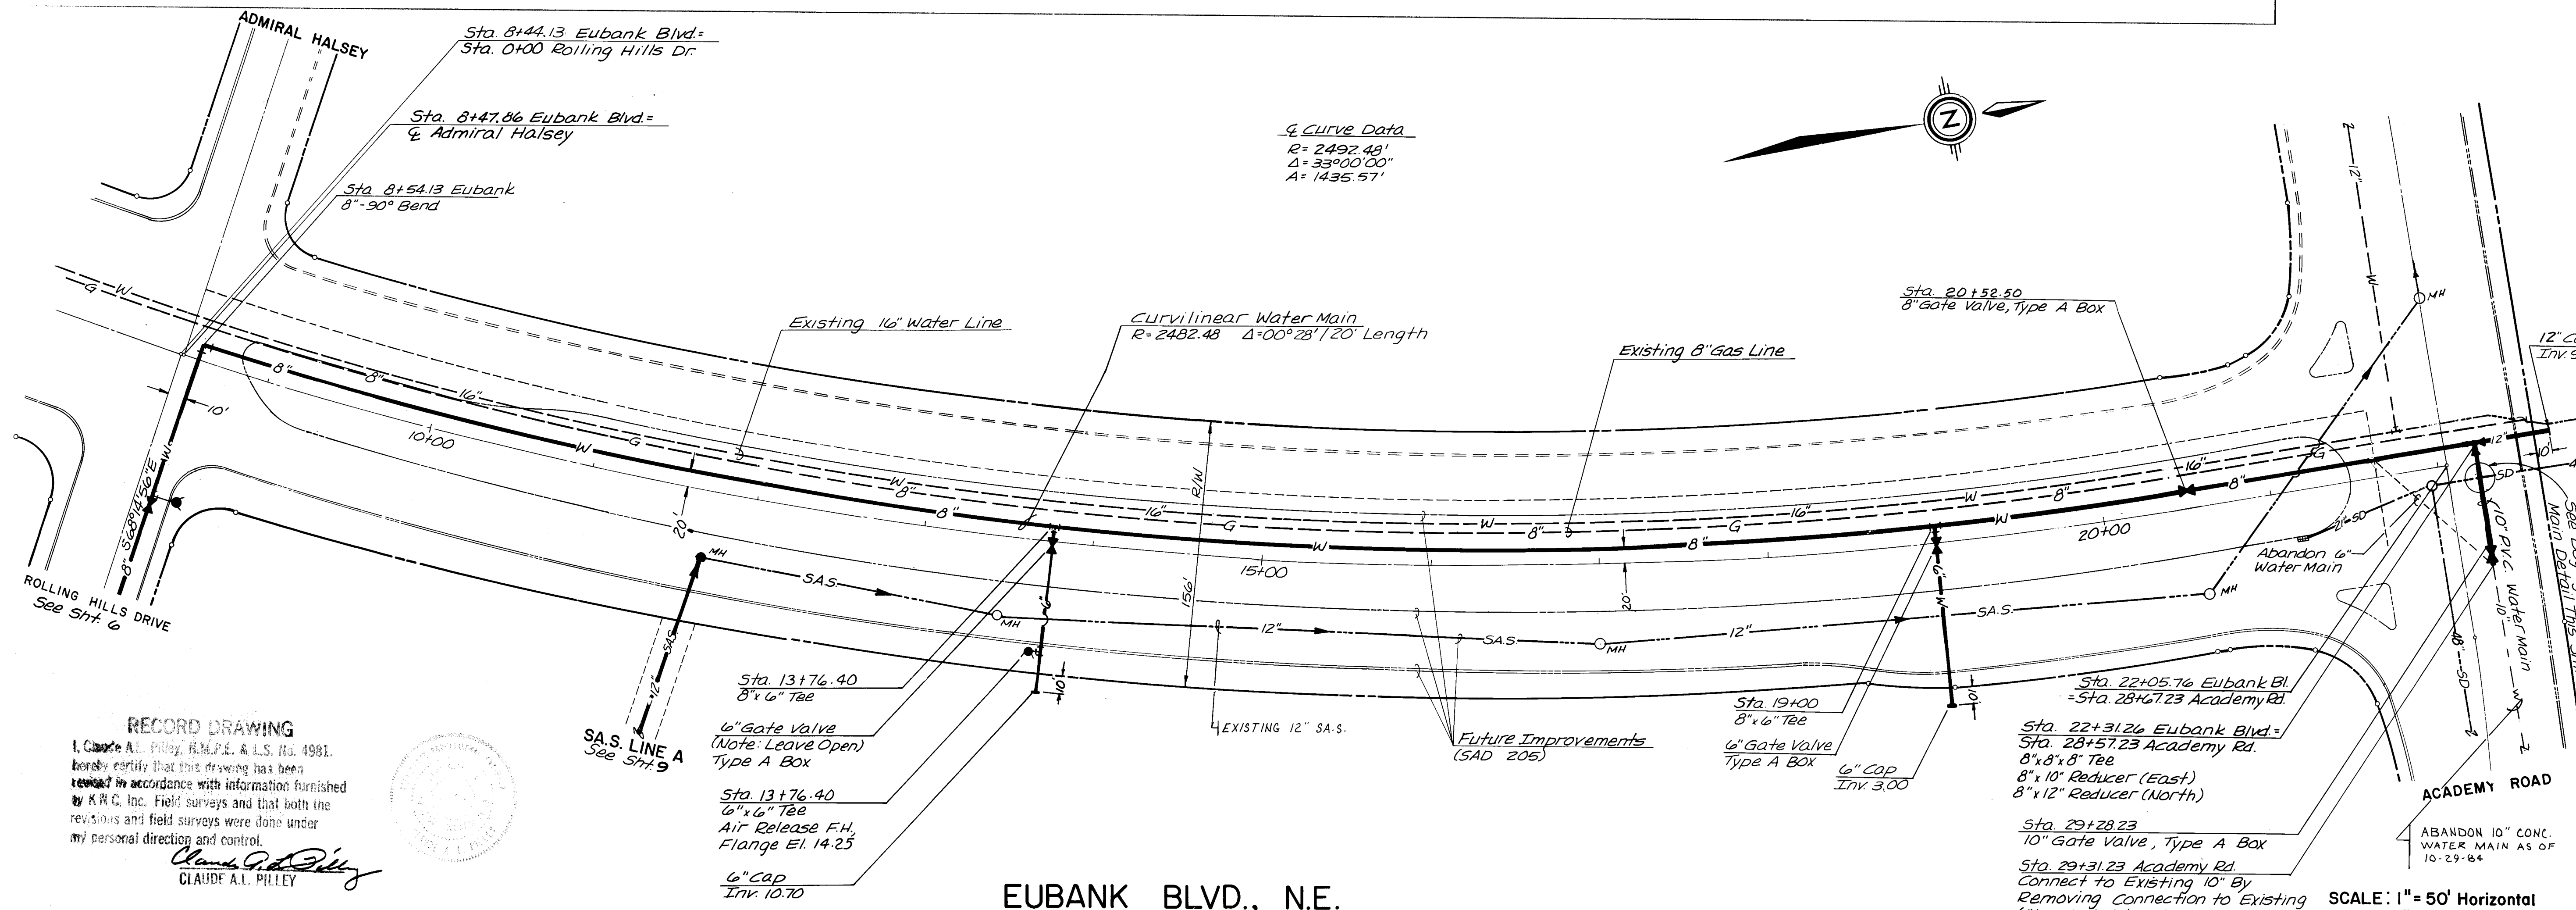

RECORD DRAWING
 I, Claude A.L. Pilley, R.M.P.E. & L.S. No. 4981,
 hereby certify that this drawing has been
 prepared in accordance with information furnished
 by K.R.C. Inc. Field surveys and that both the
 revisions and field surveys were done under
 my personal direction and control.
Claude A.L. Pilley
 CLAUDE A.L. PILLEY

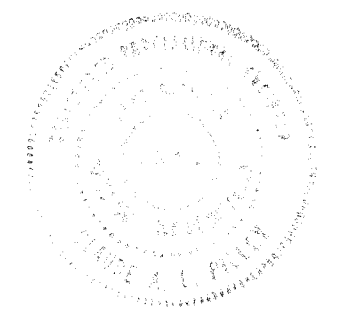

EUBANK BLVD., N.E.

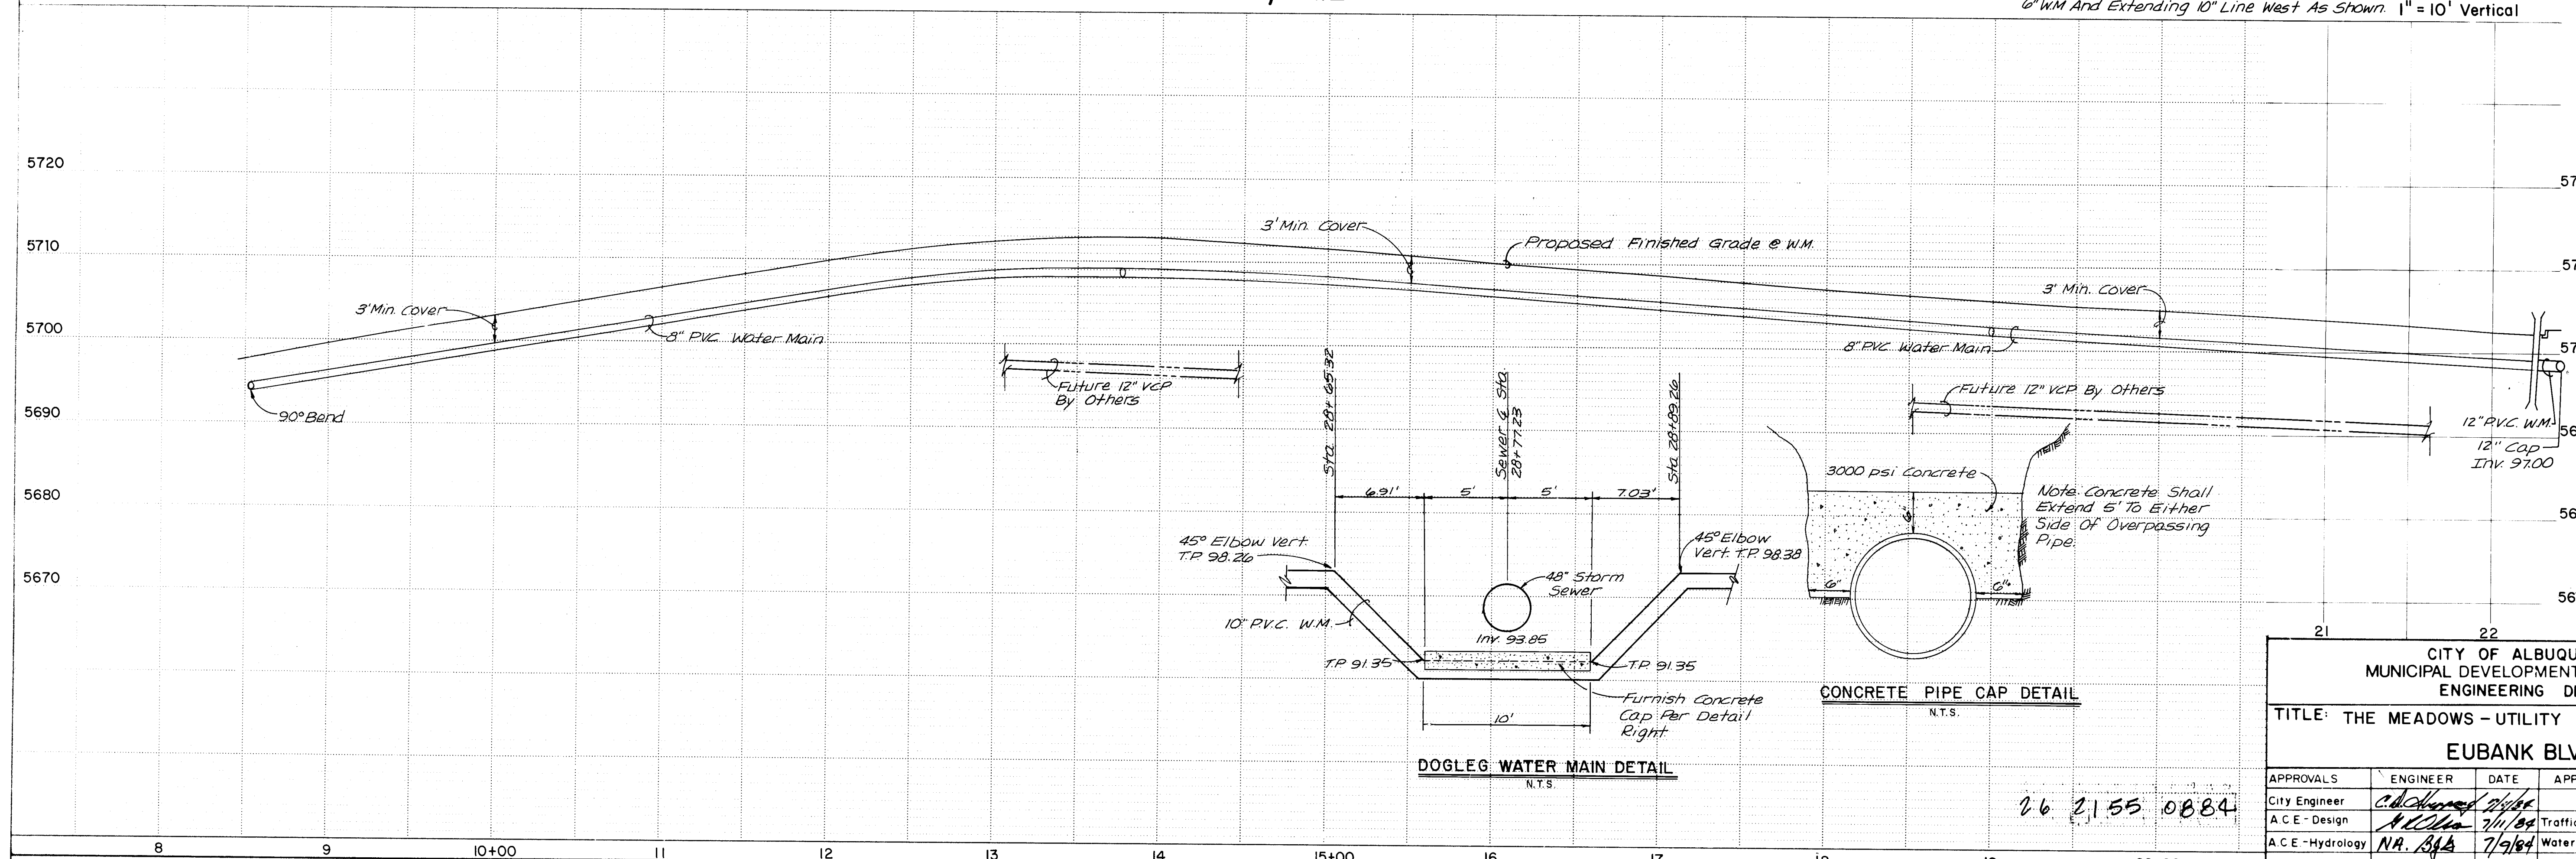


DOGLEG WATER MAIN DETAIL
 N.T.S.


CONCRETE PIPE CAP DETAIL
 N.T.S.

CITY OF ALBUQUERQUE MUNICIPAL DEVELOPMENT DEPARTMENT ENGINEERING DIVISION					
TITLE: THE MEADOWS - UTILITY PLAN AND PROFILE EUBANK BLVD., N.E.					
APPROVALS	ENGINEER	DATE	APPROVALS	ENGINEER	DATE
City Engineer	<i>Ch. Hernandez</i>	7/1/84	Traffic	<i>NA Dwyer</i>	7/10/84
A.C.E. - Design	<i>NA Dwyer</i>	7/1/84	Water Resources	<i>NA Dwyer</i>	7-7-84
A.C.E. - Hydrology	<i>NA Dwyer</i>	7/1/84			
DRAWING NO. 2155		MAP NO. E-21		SHEET 8 OF 12	

AS BUILT INFORMATION		BENCH MARKS		SURVEY INFORMATION		ENGINEER'S SEAL	
CONTRACTOR	KNC INC.	ACCS BRASS CAP "3-221A 1977" LOCATED WEST OF THE TANDON COUNTRY CLUBHOUSE AND APPROXIMATELY 1000' NORTH OF THE INTERSECTION OF SEVILLE DRIVE N.E. AND ACADEMY ROAD N.E. ELEV. = 5765.23	DATE	NO.	BY	NO.	BY
INSPECTOR'S FIELD CHECK BY		DATE					
VERIFICATION BY	M. Pohl	DATE					
CORRECTED BY		DATE					
RECORDED BY		DATE					
MICRO-FILM INFORMATION							
NO.							

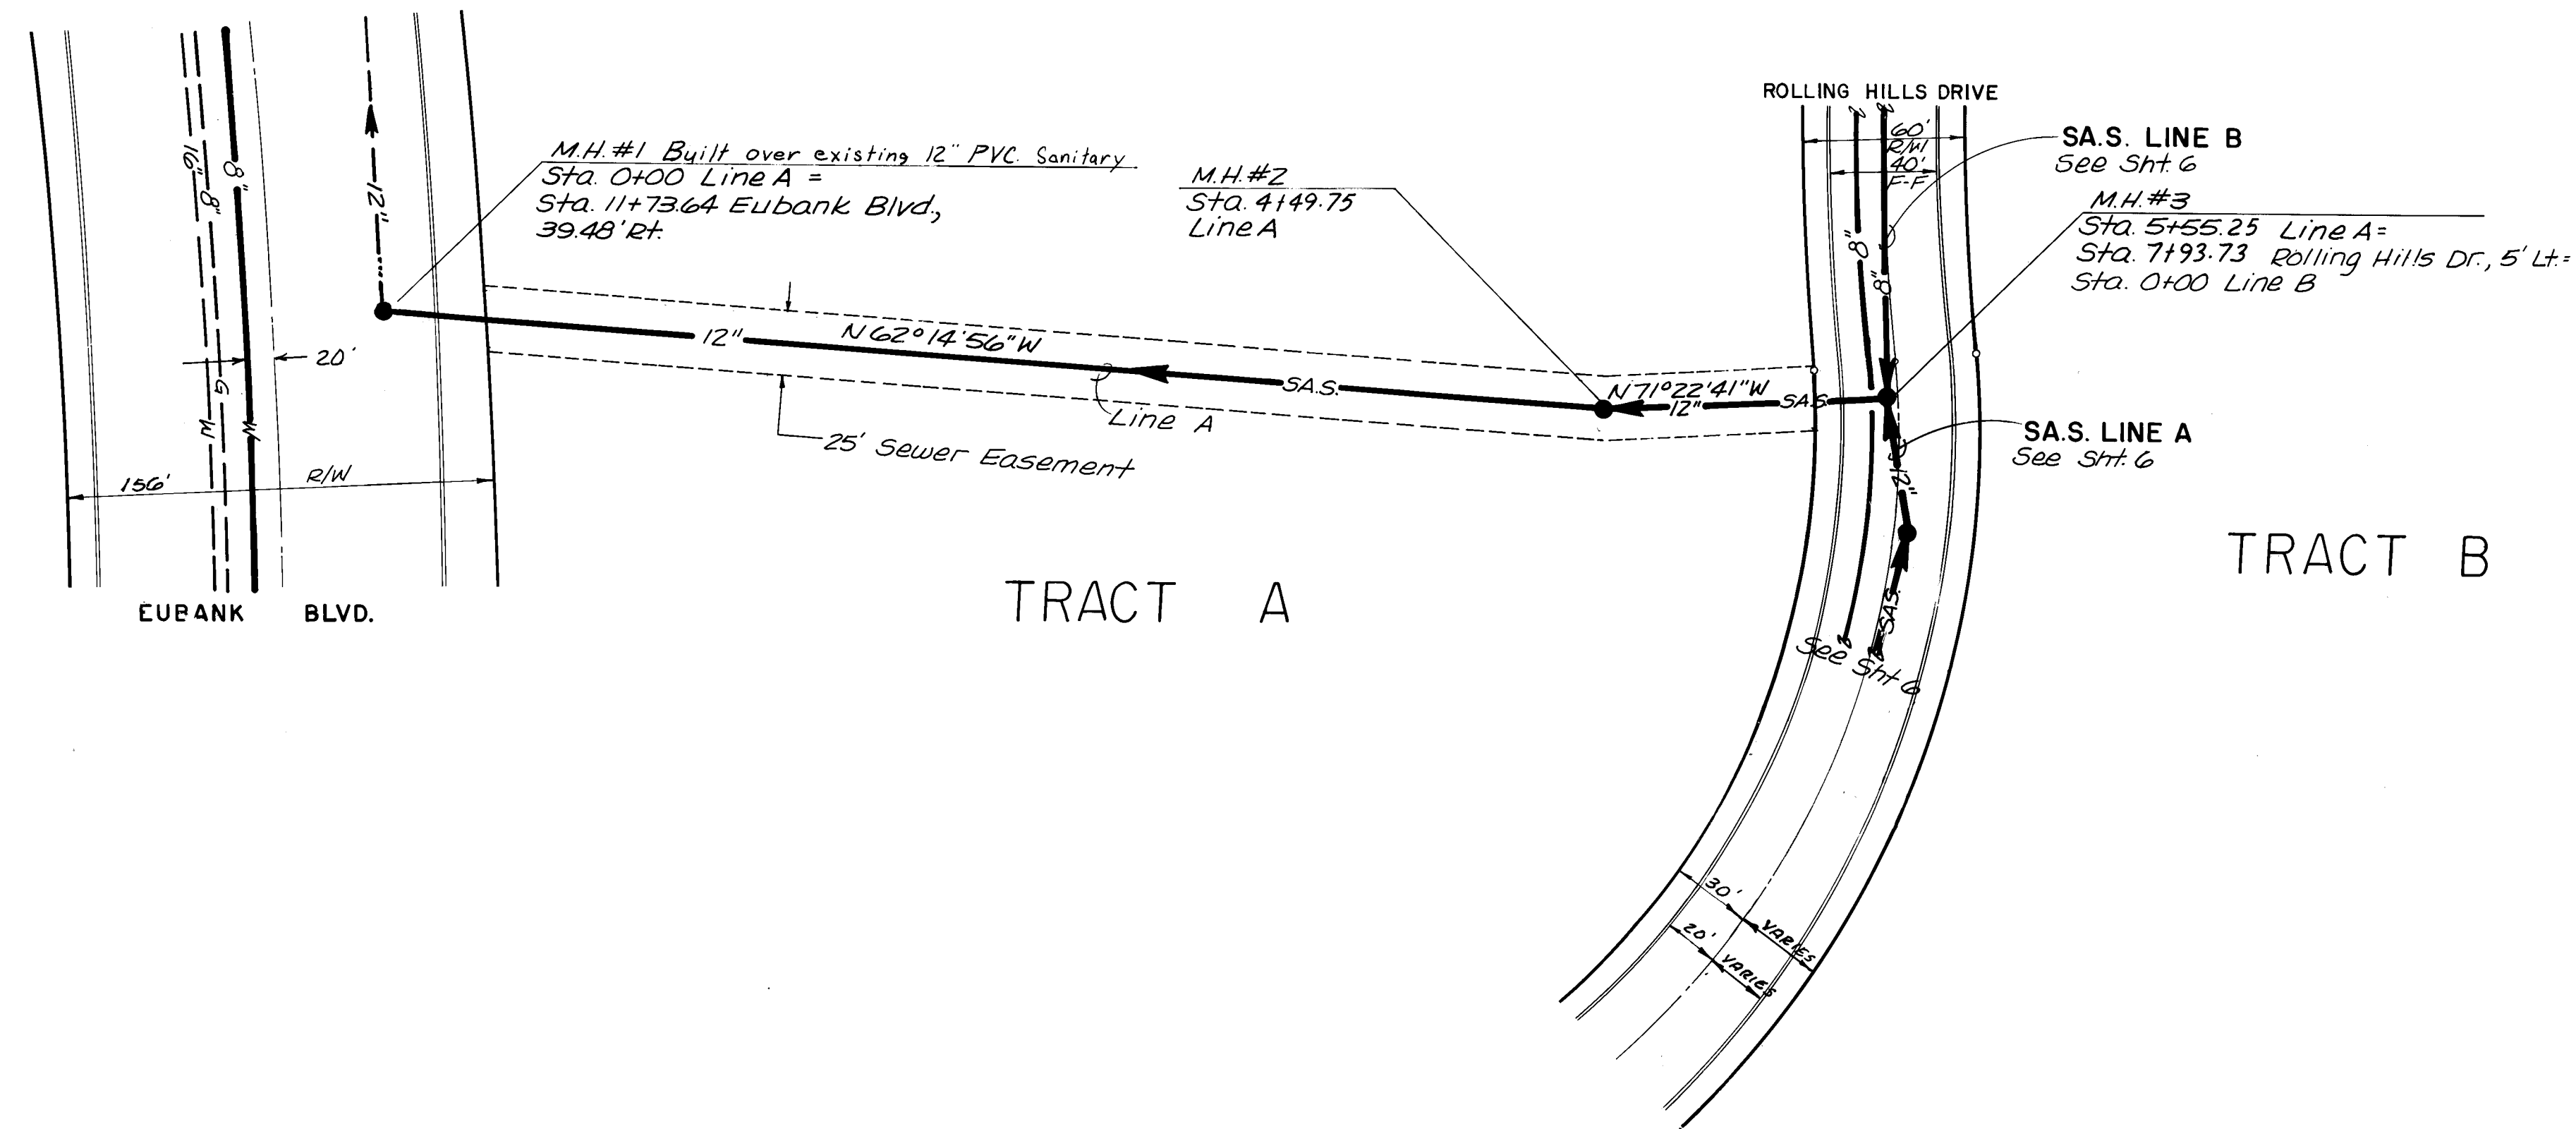

SANITARY SEWER LINE A

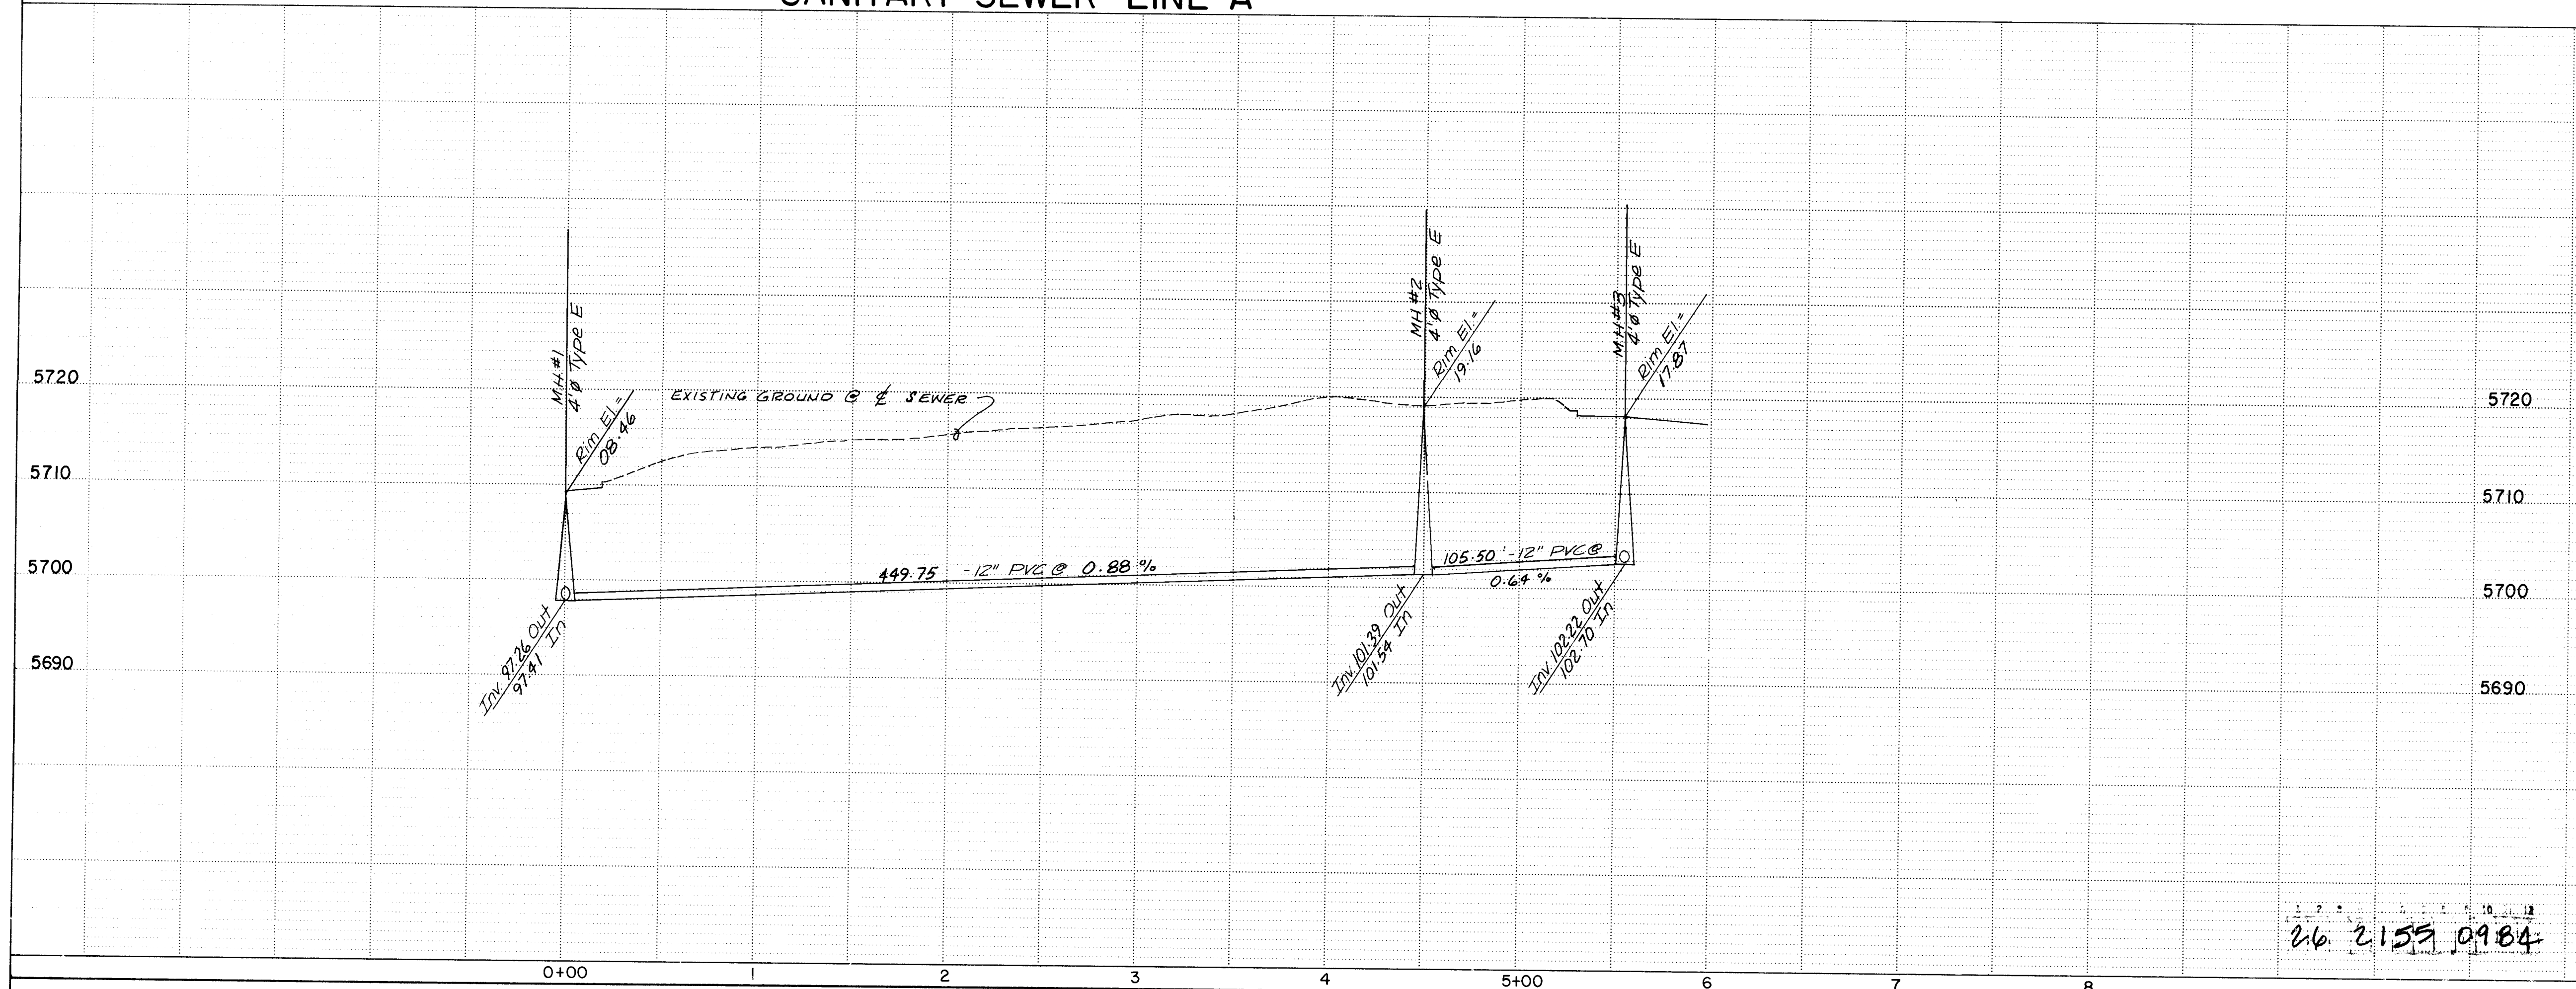

RECORD DRAWING
 I, Claude A.L. Pilley, N.M.P.E. & L.S. No. 4981,
 hereby certify that this drawing has been
 revised in accordance with information furnished
 by K.N.C. Inc. field surveys and that both the
 revisions and field work were done under
 my personal direction and control.
Claude A.L. Pilley
 CLAUDE A.L. PILLEY



SCALE: 1" = 50' Horizontal
 1" = 10' Vertical


CITY OF ALBUQUERQUE
 MUNICIPAL DEVELOPMENT DEPARTMENT
 ENGINEERING DIVISION
 TITLE: THE MEADOWS - UTILITY PLAN AND PROFILE
 SANITARY SEWER LINE A


APPROVALS	ENGINEER	DATE	APPROVALS	ENGINEER	DATE
City Engineer	<i>C.D. Pilley</i>	7/9/84	Traffic	<i>N.R. Doh</i>	7/10/84
A.C.E. - Design	<i>H. L. Lina</i>	7/11/84	Water Resources	<i>R. Kera</i>	7-9-84
A.C.E. - Hydrology	<i>N.A. B. B.</i>	7/9/84			

DRAWING NO. 2155 MAP NO. E-21 SHEET 9 OF 12

SURVEY INFORMATION		BENCH MARKS		AS BUILT INFORMATION	
NO.	BY	DATE	DATE	CONTRACTOR	K.N.C. INC.
				INSPECTED BY	
				DATE	
				APPROVED BY	
				DATE	
				RECORDED BY	
				DATE	
				NO.	

 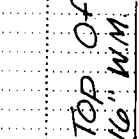

 SCALE: 1" = 50' Horizontal 1" = 10' Vertical						DESIGNED		DRAWN BY		CHECKED	
CITY OF ALBUQUERQUE MUNICIPAL DEVELOPMENT DEPARTMENT ENGINEERING DIVISION											
TITLE: THE MEADOWS - UTILITY PLAN AND PROFILE SANITARY SEWER LINE A											
APPROVALS		ENGINEER		DATE		APPROVALS		ENGINEER		DATE	
City Engineer		<i>E. J. [Signature]</i>		7/16/84							
A.C.E. - Design		<i>R. [Signature]</i>		7/16/84		Traffic		N.A. Dwy		7/16/84	
A.C.E. - Hydrology		<i>N.H. [Signature]</i>		7/9/84		Water Resources		<i>R. [Signature]</i>		7-9-84	
DRAWING NO.		2155		MAP NO.		E-21		SHEET		OF	
						30		10		12	

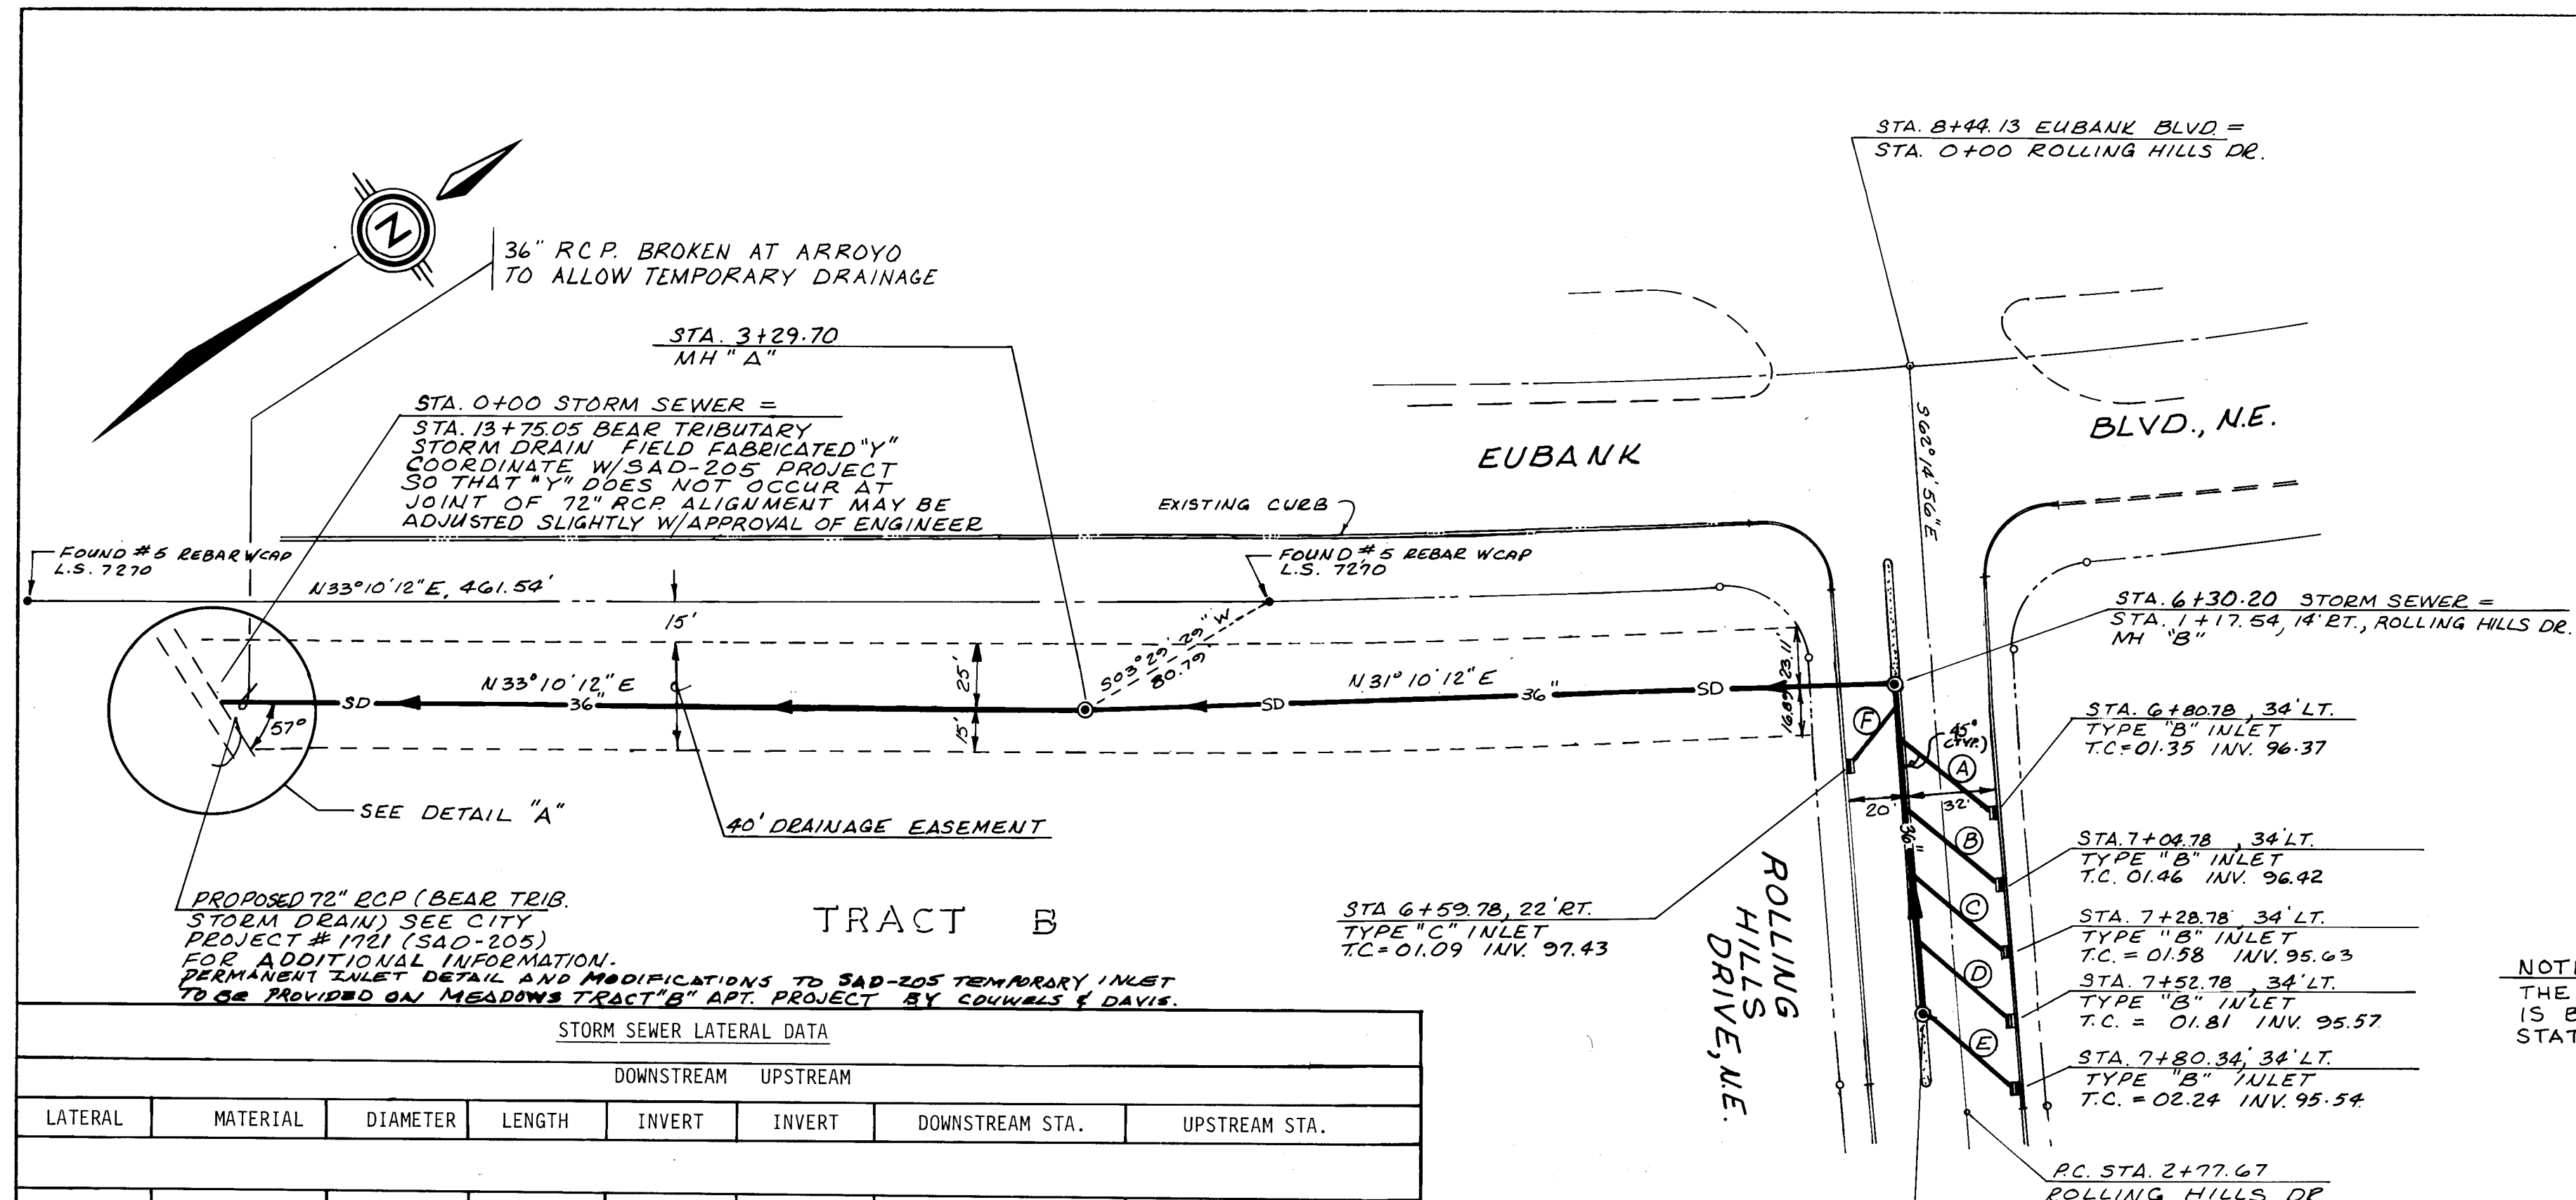



STORM SEWER LATERAL DATA							
DOWNSTREAM				UPSTREAM			
LATERAL	MATERIAL	DIAMETER	LENGTH	INVERT	INVERT	DOWNSTREAM STA.	UPSTREAM STA.
A	RCP	18"	40.19	90.49	96.37	6+52.28, 1.5' LT	6+80.78, 30' LT
B	RCP	18"	40.19	91.00	96.42	6+76.28, 1.5' LT	7+04.78, 30' LT
C	RCP	18"	40.19	91.51	95.63	7+00.28, 1.5' LT	7+28.78, 30' LT
D	RCP	24"	40.19	92.02	95.57	7+24.28, 1.5' LT	7+52.78, 30' LT
E	RCP	24"	38.08	92.64	95.54	7+53.41, 2.13' LT	7+80.34, 30' LT
F	RCP	18"	26.09	90.26	97.43	6+41.28, 1.5' RT	6+59.78, 20' RT

RECORD DRAWING

I, Claude A.L. Pilley, R.M.P.C. & L.S. No. 4081, hereby certify that this drawing was prepared in accordance with information furnished by K.N.C., Inc. Field surveys and that both the revisions and field surveys were done under my personal direction and control.



Claude A.L. Pilley

CLAUDE A.L. PILLEY

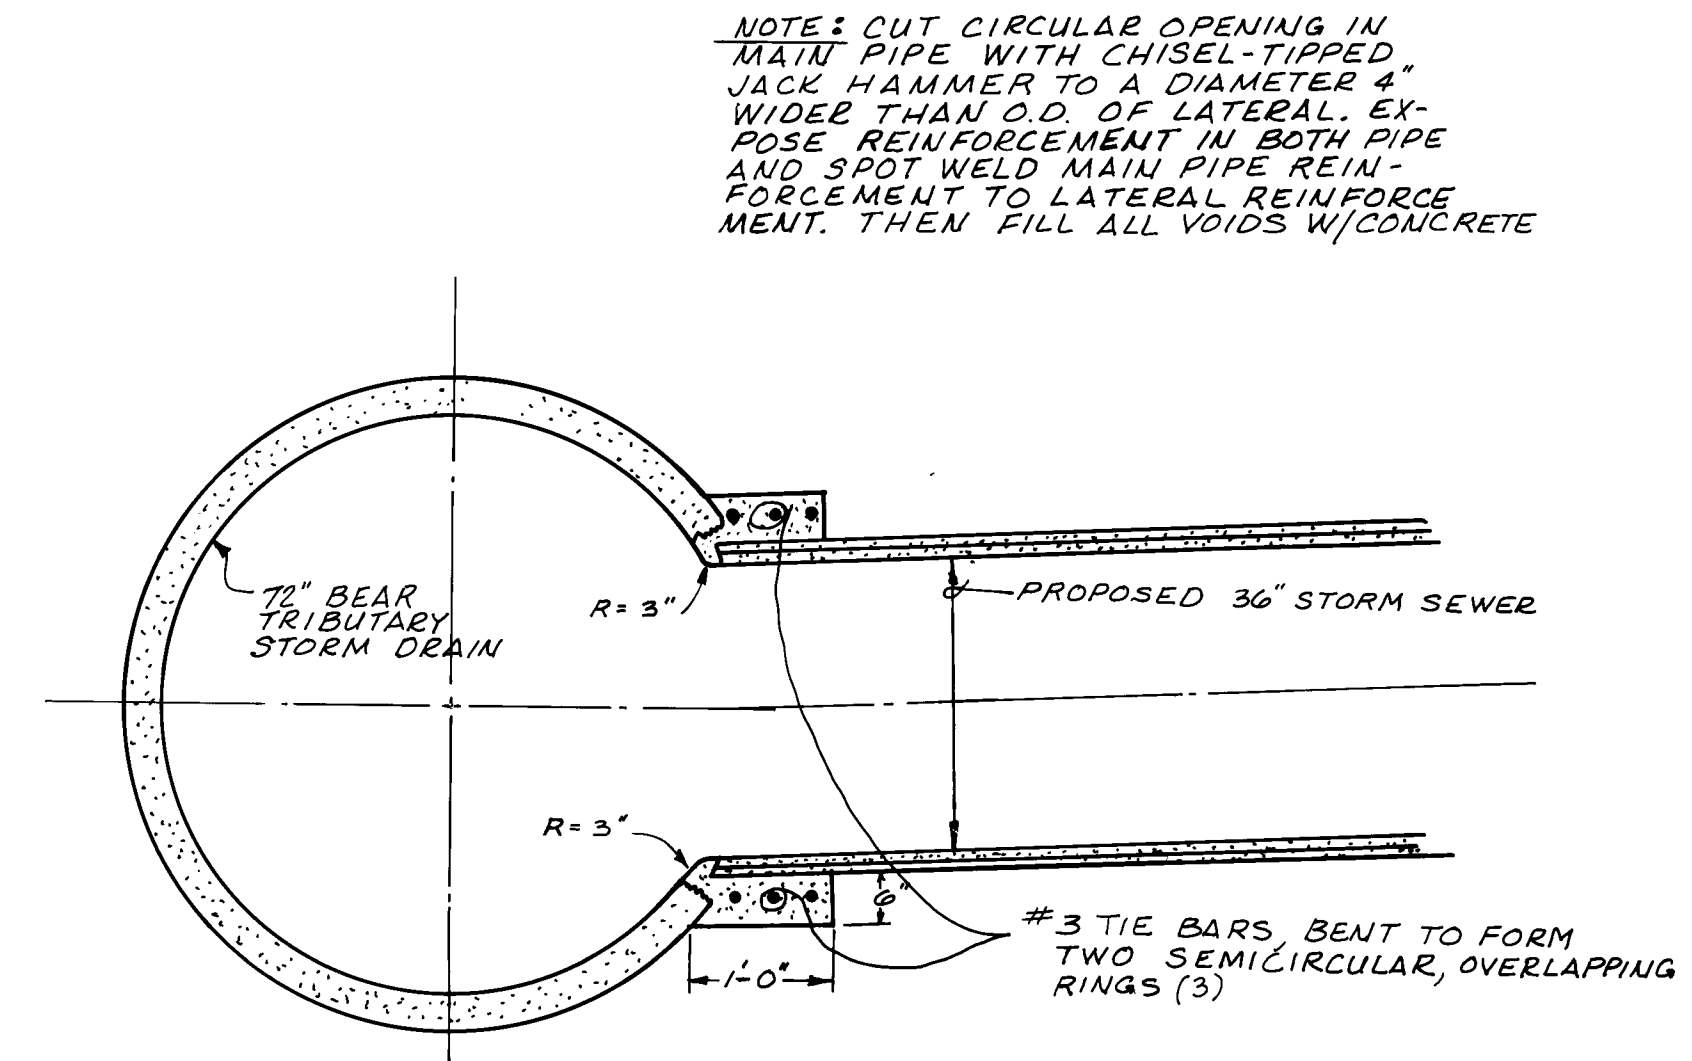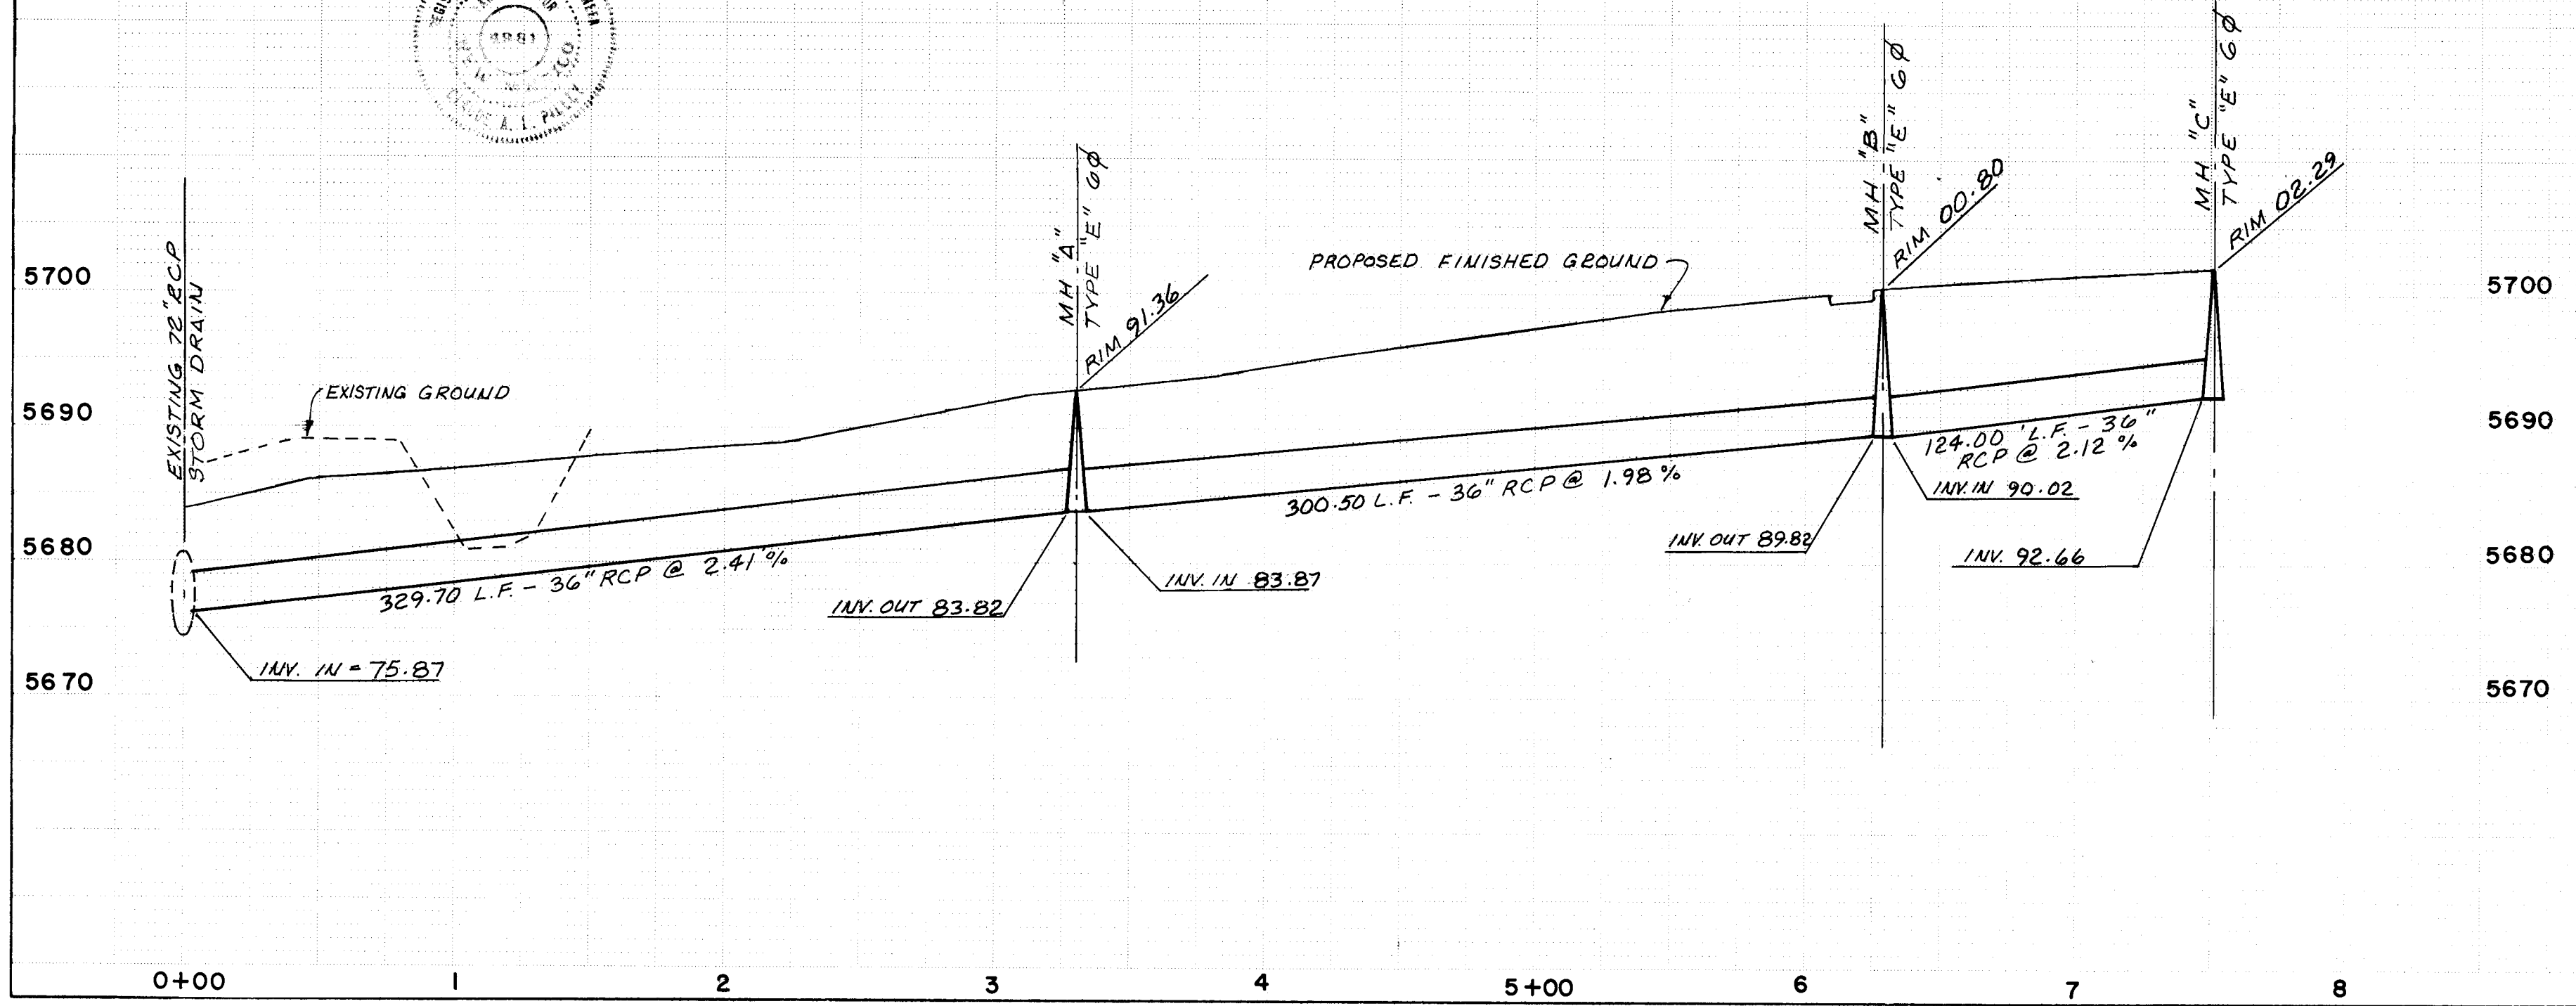

NOTE: THE STATIONING FOR INLETS IS BASED ON STORM SEWER STATIONING.


NOTE ON BENCHWORK: MANHOLE BENCHWORK SHALL CONSIST OF 3000 PSI CONCRETE SHALL CONFORM TO THE CROSS SECTION OF THE PIPE UP TO THE PIPE SPRING LINE, AND SHALL BE VERTICAL-WALLED THERE AFTER EXTENDING UP TO THE ELEVATION OF THE PIPE SOFFIT.

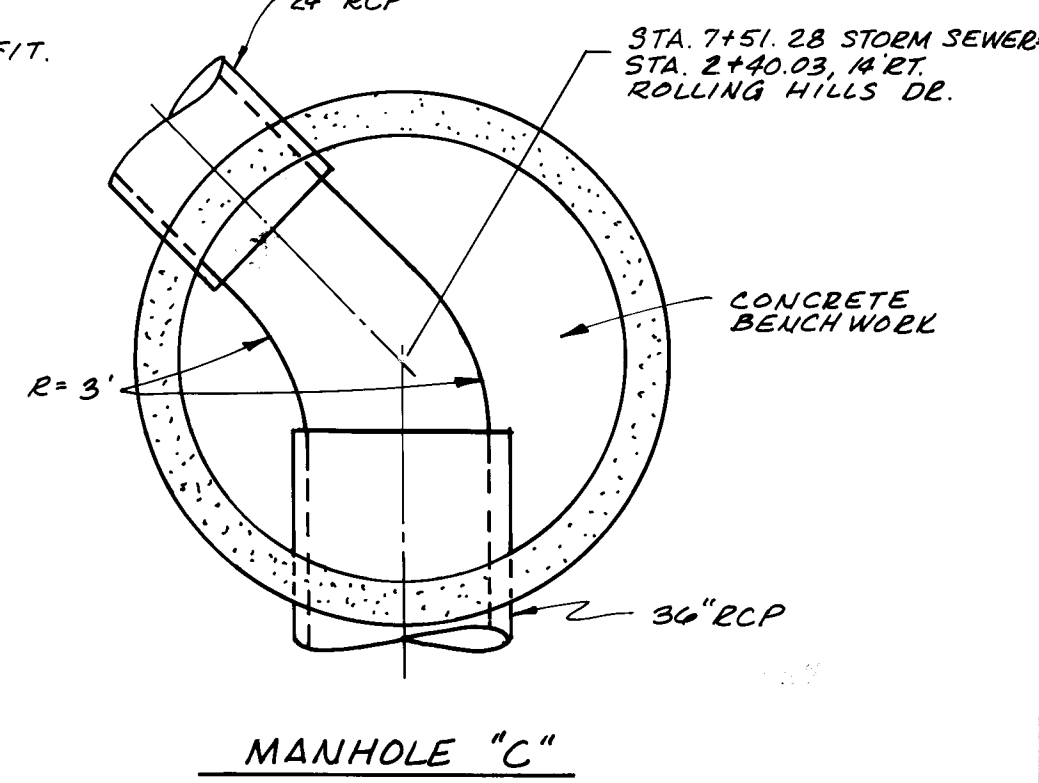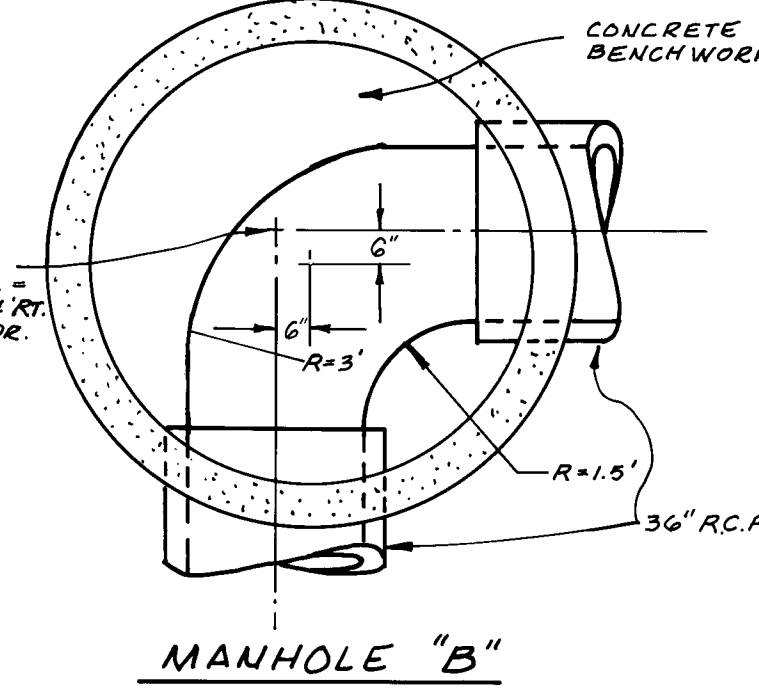

STORM SEWER MANHOLE BENCHWORK

N.T.S.

NOTE: THE 8' LENGTHS OF 36" RCP ARE TO BE PLACED SO THAT LATERAL CONNECTIONS ARE NOT AT THE JOINTS.

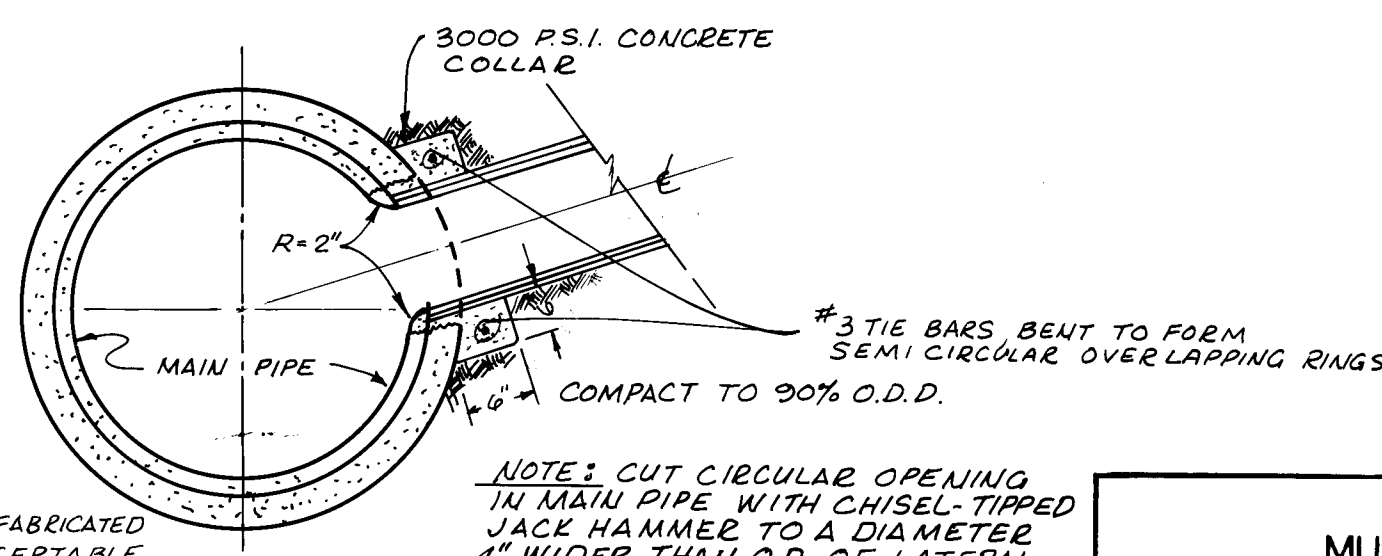

2155 2155 1284

AS BUILT INFORMATION		BENCH MARKS		SURVEY INFORMATION		ENGINEER'S SEAL		REVISIONS		CITY OF ALBUQUERQUE																									
CONTRACTOR	KNC, INC.	WORKED BY	DATE	NO.	DATE	NO.	DATE	NO.	DATE	NO.	DATE																								
INSPECTED BY	DATE	NO.	DATE	NO.	DATE	NO.	DATE	NO.	DATE	NO.	DATE																								
ACCURACY BY	DATE	NO.	DATE	NO.	DATE	NO.	DATE	NO.	DATE	NO.	DATE																								
VERIFICATION BY	DATE	NO.	DATE	NO.	DATE	NO.	DATE	NO.	DATE	NO.	DATE																								
DRAWING NO.	2155	NO.	DATE	NO.	DATE	NO.	DATE	NO.	DATE	NO.	DATE																								
CITY OF ALBUQUERQUE MUNICIPAL DEVELOPMENT DEPARTMENT ENGINEERING DIVISION TITLE: THE MEADOWS-UTILITY PLAN AND PROFILE 36" STORM SEWER & DETAILS <table border="1"> <tr> <th>APPROVALS</th> <th>ENGINEER</th> <th>DATE</th> <th>APPROVALS</th> <th>ENGINEER</th> <th>DATE</th> </tr> <tr> <td>City Engineer</td> <td><i>C. A. Pilley</i></td> <td>9/19/84</td> <td>Liquid Waste</td> <td><i>R. Pena</i></td> <td>8/29/84</td> </tr> <tr> <td>A.C.E. - Design</td> <td><i>G. R. Pena</i></td> <td>9/19/84</td> <td>Traffic</td> <td><i>N. D. H.</i></td> <td>8/29/84</td> </tr> <tr> <td>Hydrology</td> <td><i>B. J. Pena</i></td> <td>8/29/84</td> <td>Water</td> <td><i>R. Pena</i></td> <td>8/29/84</td> </tr> </table>												APPROVALS	ENGINEER	DATE	APPROVALS	ENGINEER	DATE	City Engineer	<i>C. A. Pilley</i>	9/19/84	Liquid Waste	<i>R. Pena</i>	8/29/84	A.C.E. - Design	<i>G. R. Pena</i>	9/19/84	Traffic	<i>N. D. H.</i>	8/29/84	Hydrology	<i>B. J. Pena</i>	8/29/84	Water	<i>R. Pena</i>	8/29/84
APPROVALS	ENGINEER	DATE	APPROVALS	ENGINEER	DATE																														
City Engineer	<i>C. A. Pilley</i>	9/19/84	Liquid Waste	<i>R. Pena</i>	8/29/84																														
A.C.E. - Design	<i>G. R. Pena</i>	9/19/84	Traffic	<i>N. D. H.</i>	8/29/84																														
Hydrology	<i>B. J. Pena</i>	8/29/84	Water	<i>R. Pena</i>	8/29/84																														
DRAWING NO.	2155	MAP NO.	E-21	SHEET	12	OF	12																												