

PROFILE	SEARCHED	INDEXED	FILED	DATE
NOTE BOOK	PLOTTED			
C. M. RYDLO	GRAD'S BREAKED			
NO	STANDARD MOTIONS CHART			

FRONT SECTION


SIDE SECTION

FRONT ELEVATION

SIDE ELEVATION

[illegible]

DETAILS OF HEADWALL

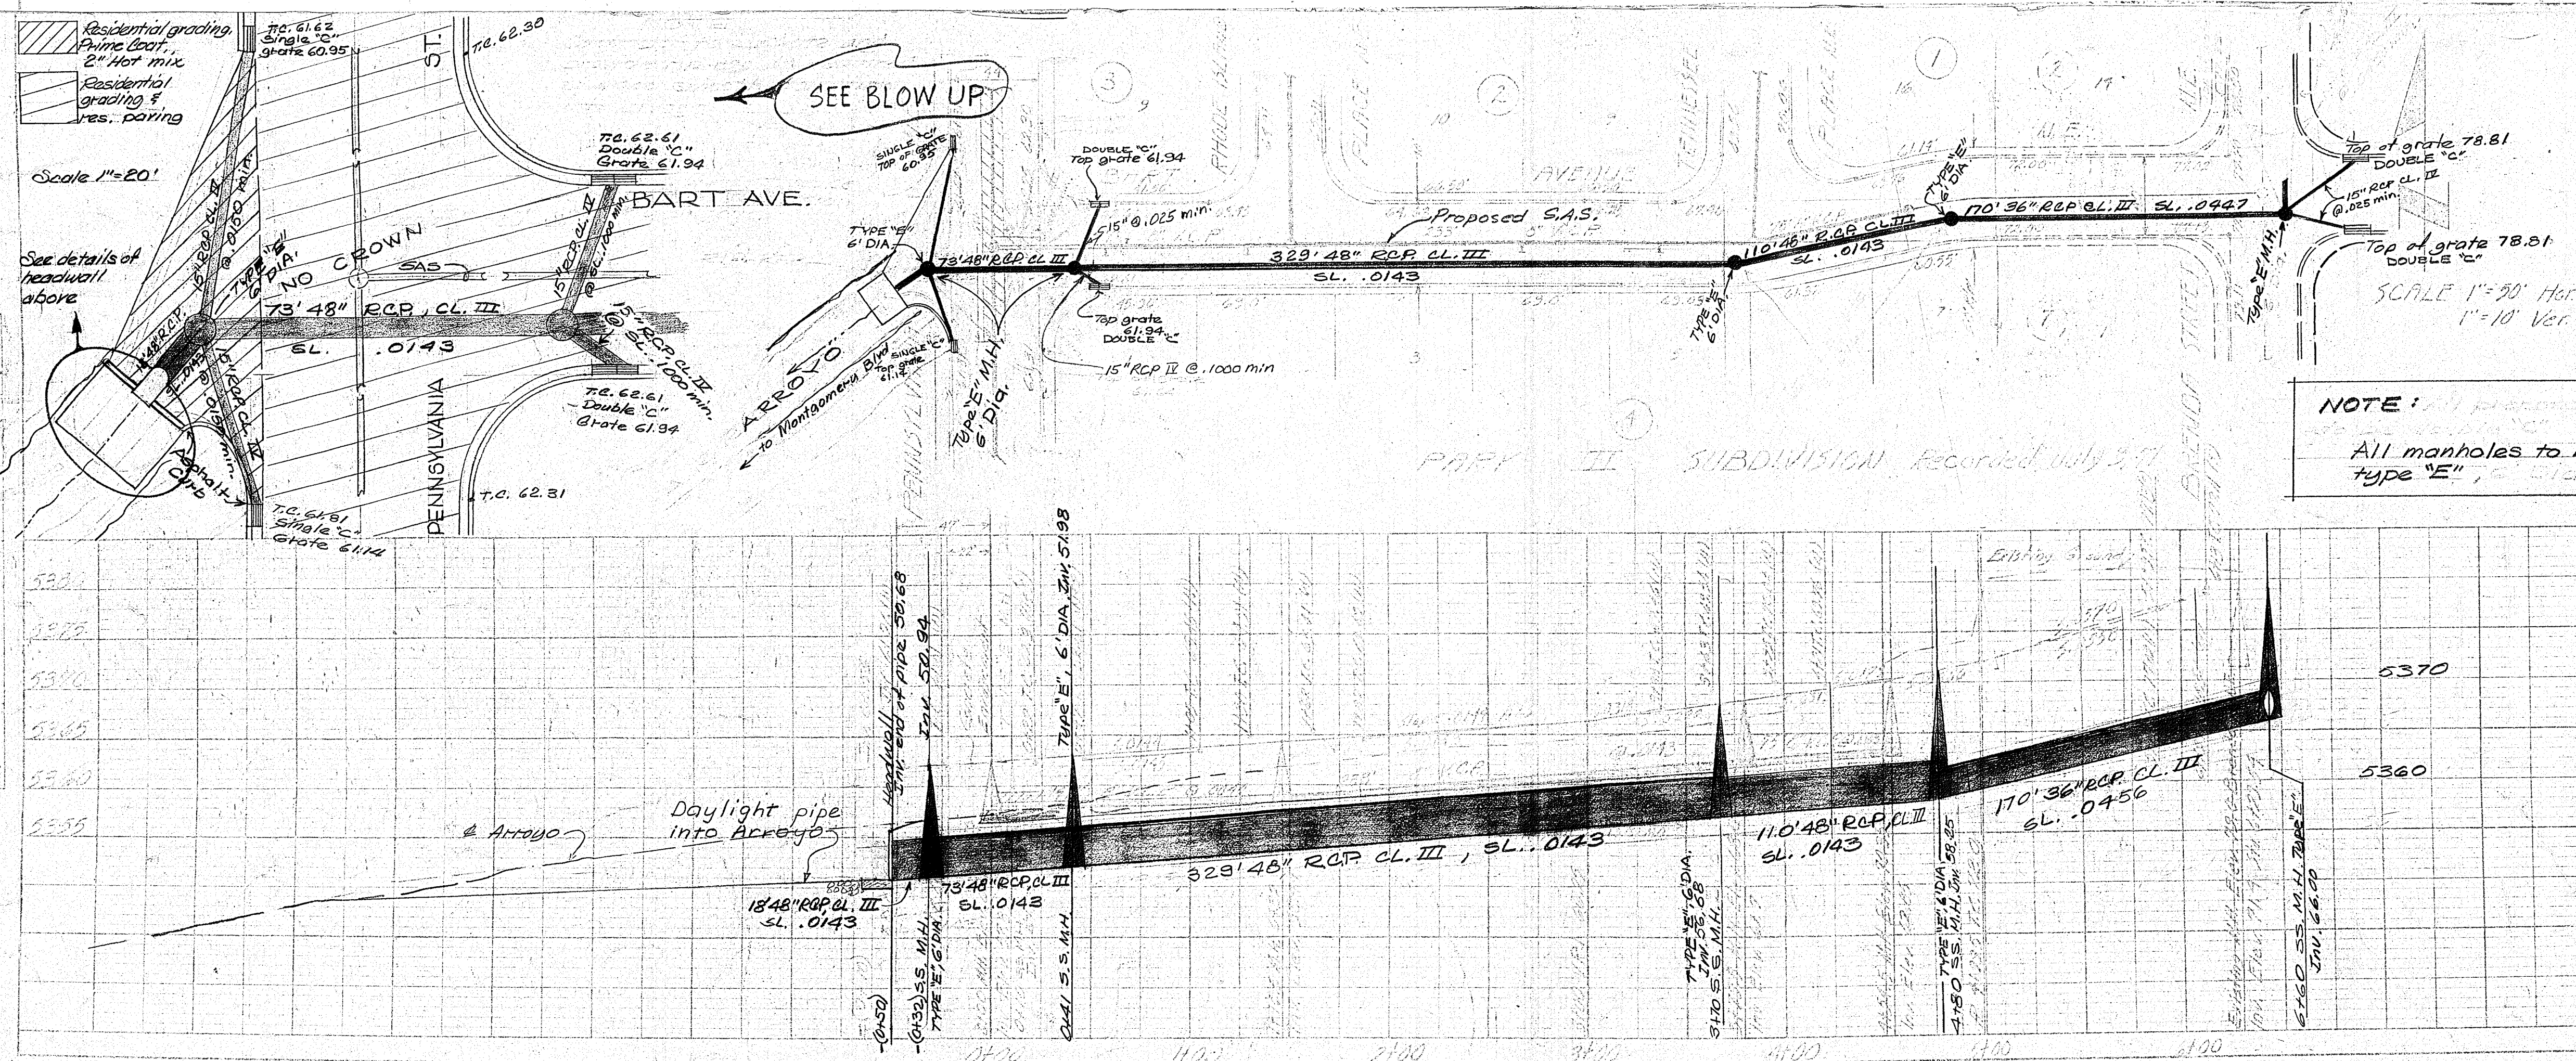

MEGETH

1. BENCH MARK: Mannolo at intersection of Montgomery Blvd. H-2 and Pennsylvania. Pin Allen 2345.13
2. Return radius for curb and gutter to be 25 feet unless otherwise noted
3. Manhole bases to be poured in place.
4. Curb and gutter to be standard type.
5. Plat filed July 3, 1981.


NOTE:

All manholes to be type "E", 6' dia.

		SS-16-71		5380
		Map No. F-19-S		5375
		CITY OF ALBUQUERQUE		5370
		PUBLIC WORKS DEPARTMENT		5365
		ENGINEERING DIVISION		5360
TITLE		SMALL BRIDGE & DRAIN DESIGN ON FARM IN SOUTHWEST CO.		5355
DESIGNED BY		APPROVED BY FJB		5350
DATE		DATE 9/16/71 TITLE ACE		5345
EXAMINED BY CEHA		APPROVED BY RAH		5340
DATE 9/23/71		DATE 9/23/71 TITLE WES		5335
DRAWN BY		APPROVED BY WES		5330
DATE		DATE 9/24/71 TITLE CE		5325
CHECKED BY CT		APPROVED BY		5320
DATE 9/17/71 TITLE CEH		DATE		5315
REV. 1		NOTES		5310
REV. 2		NOTES		5305
REV. 3		NOTES		5300
		SS-16-71		5295
		SHEET NO. 2		5290
		2 534475		5285

PLAN	DATE	
	BY	
	SURVEYED	
	PLOTTED	
	NOTE BOOK	
	NO.	


PROFILE	DATE	
	BY	
	SURVEYED	
	GRADES CHECKED	
	NOTE BOOK	
	NO.	

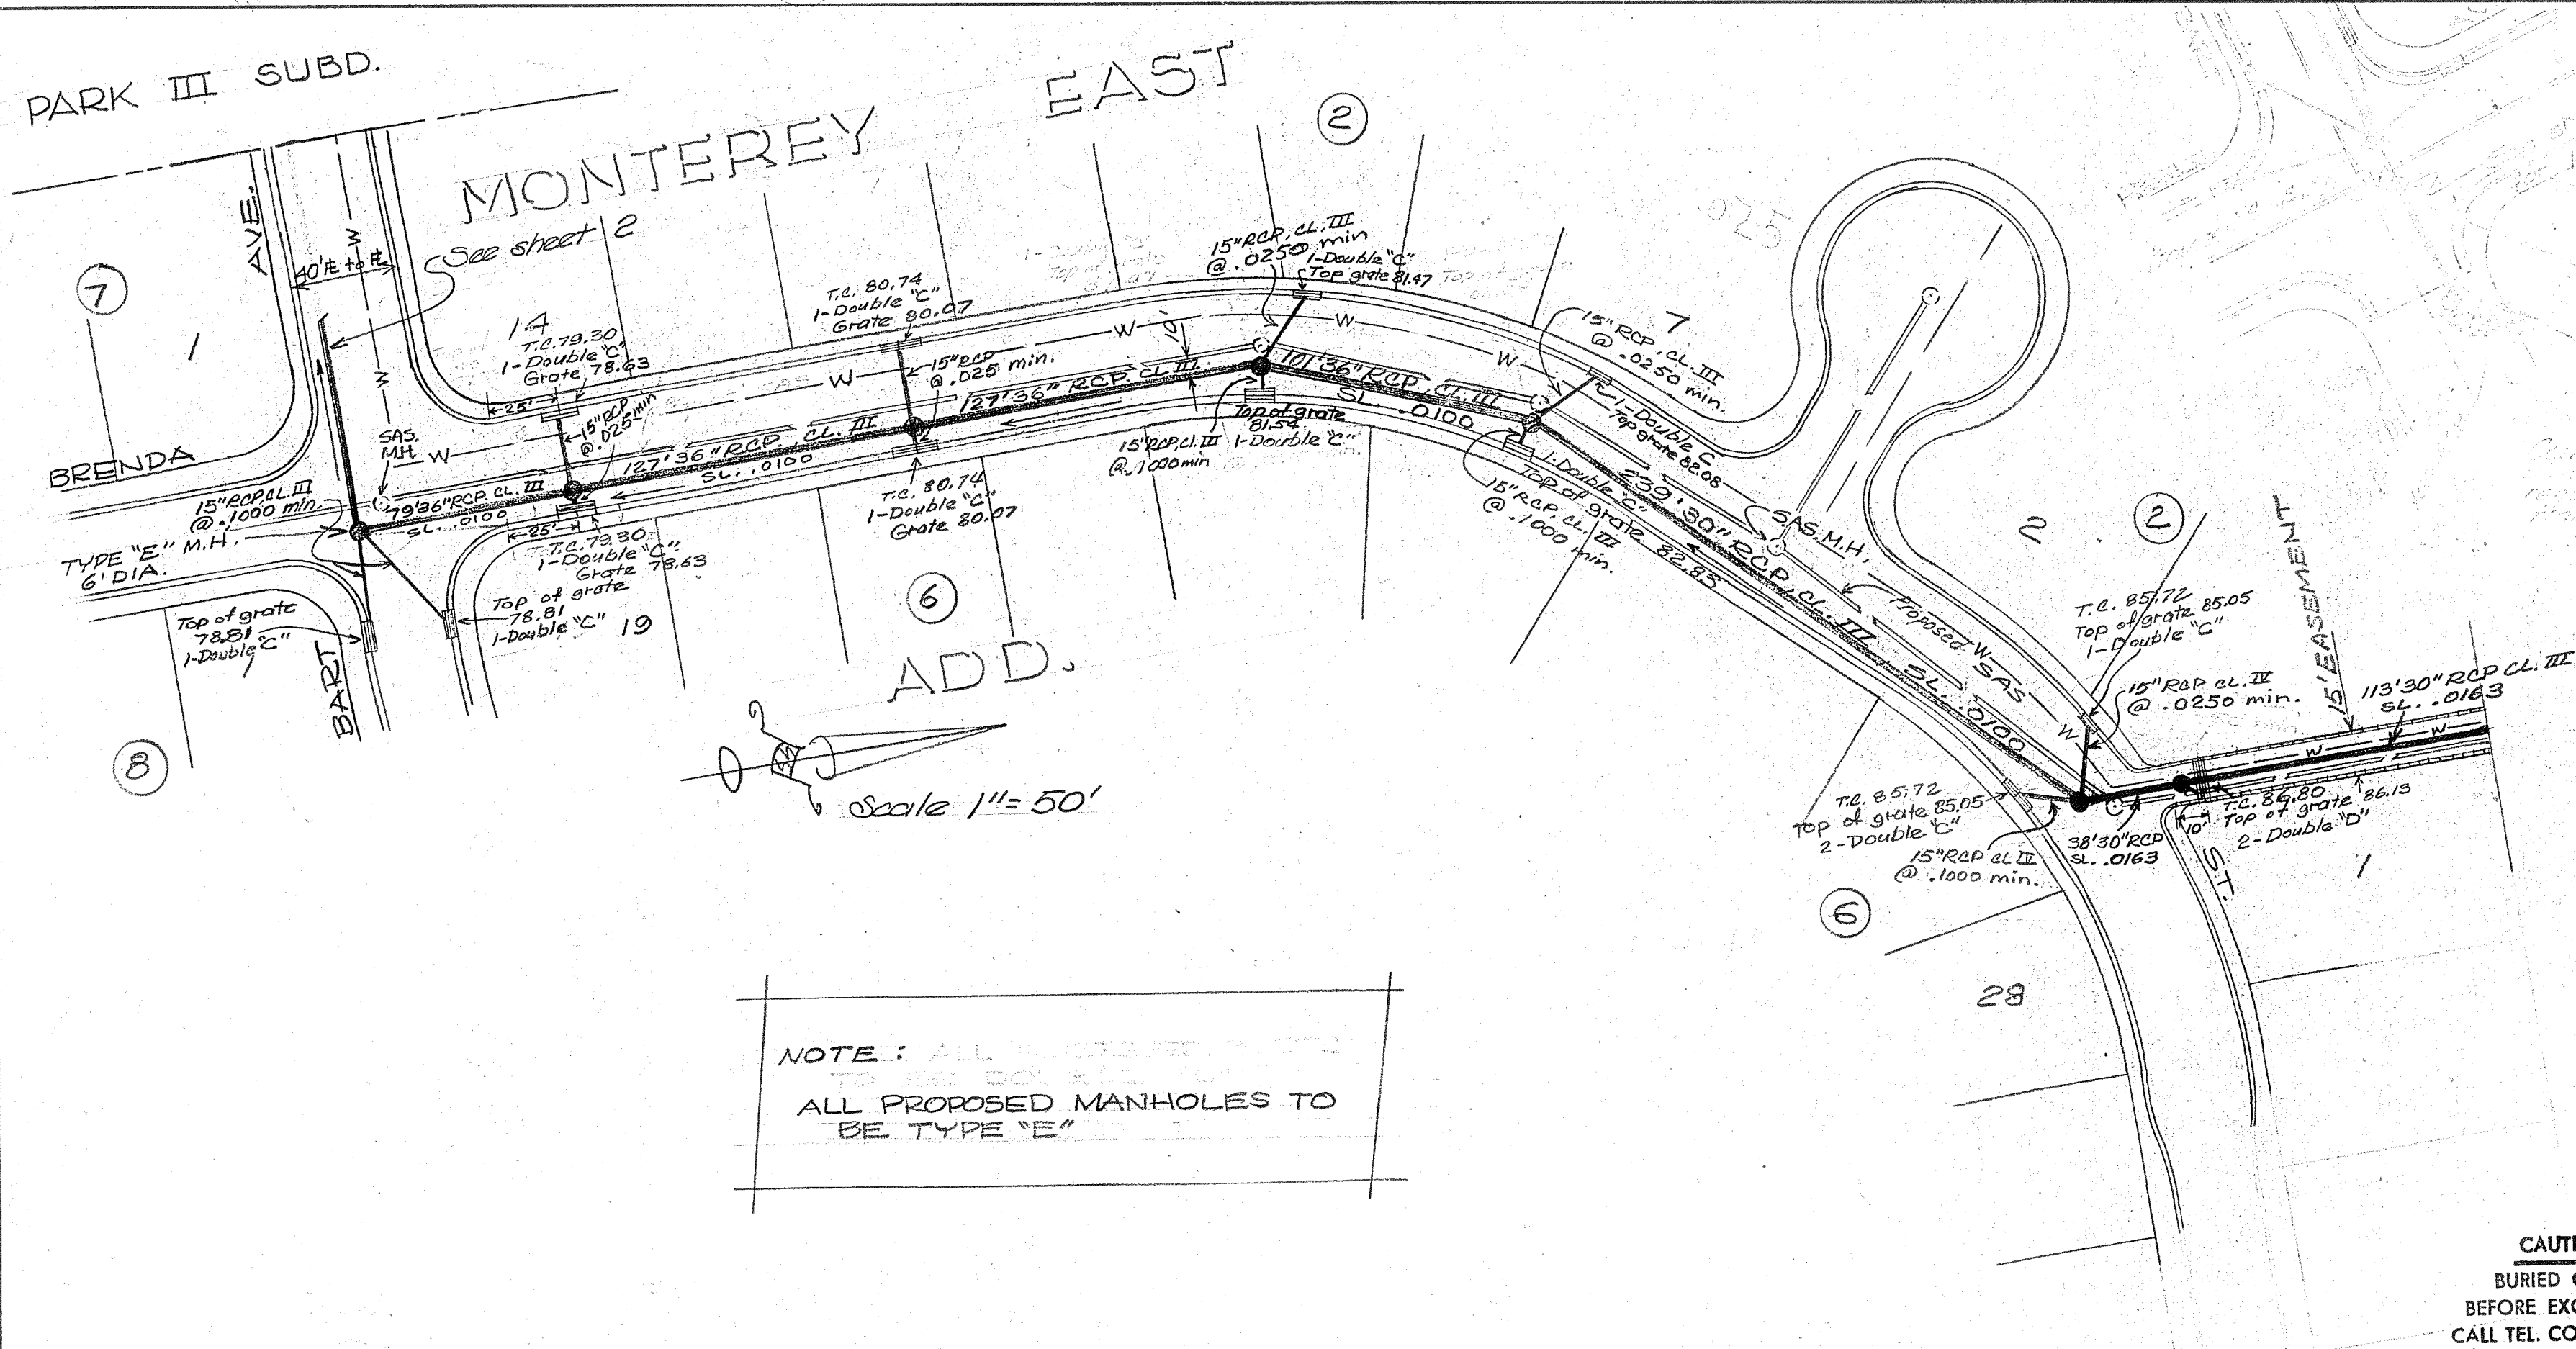

NOTE: ALL PROPOSED MANHOLES TO BE TYPE "E"

CAUTION!
BURIED CABLES
BEFORE EXCAVATING
CALL TEL. CO. 842-1211

02 16 0171 01 61192

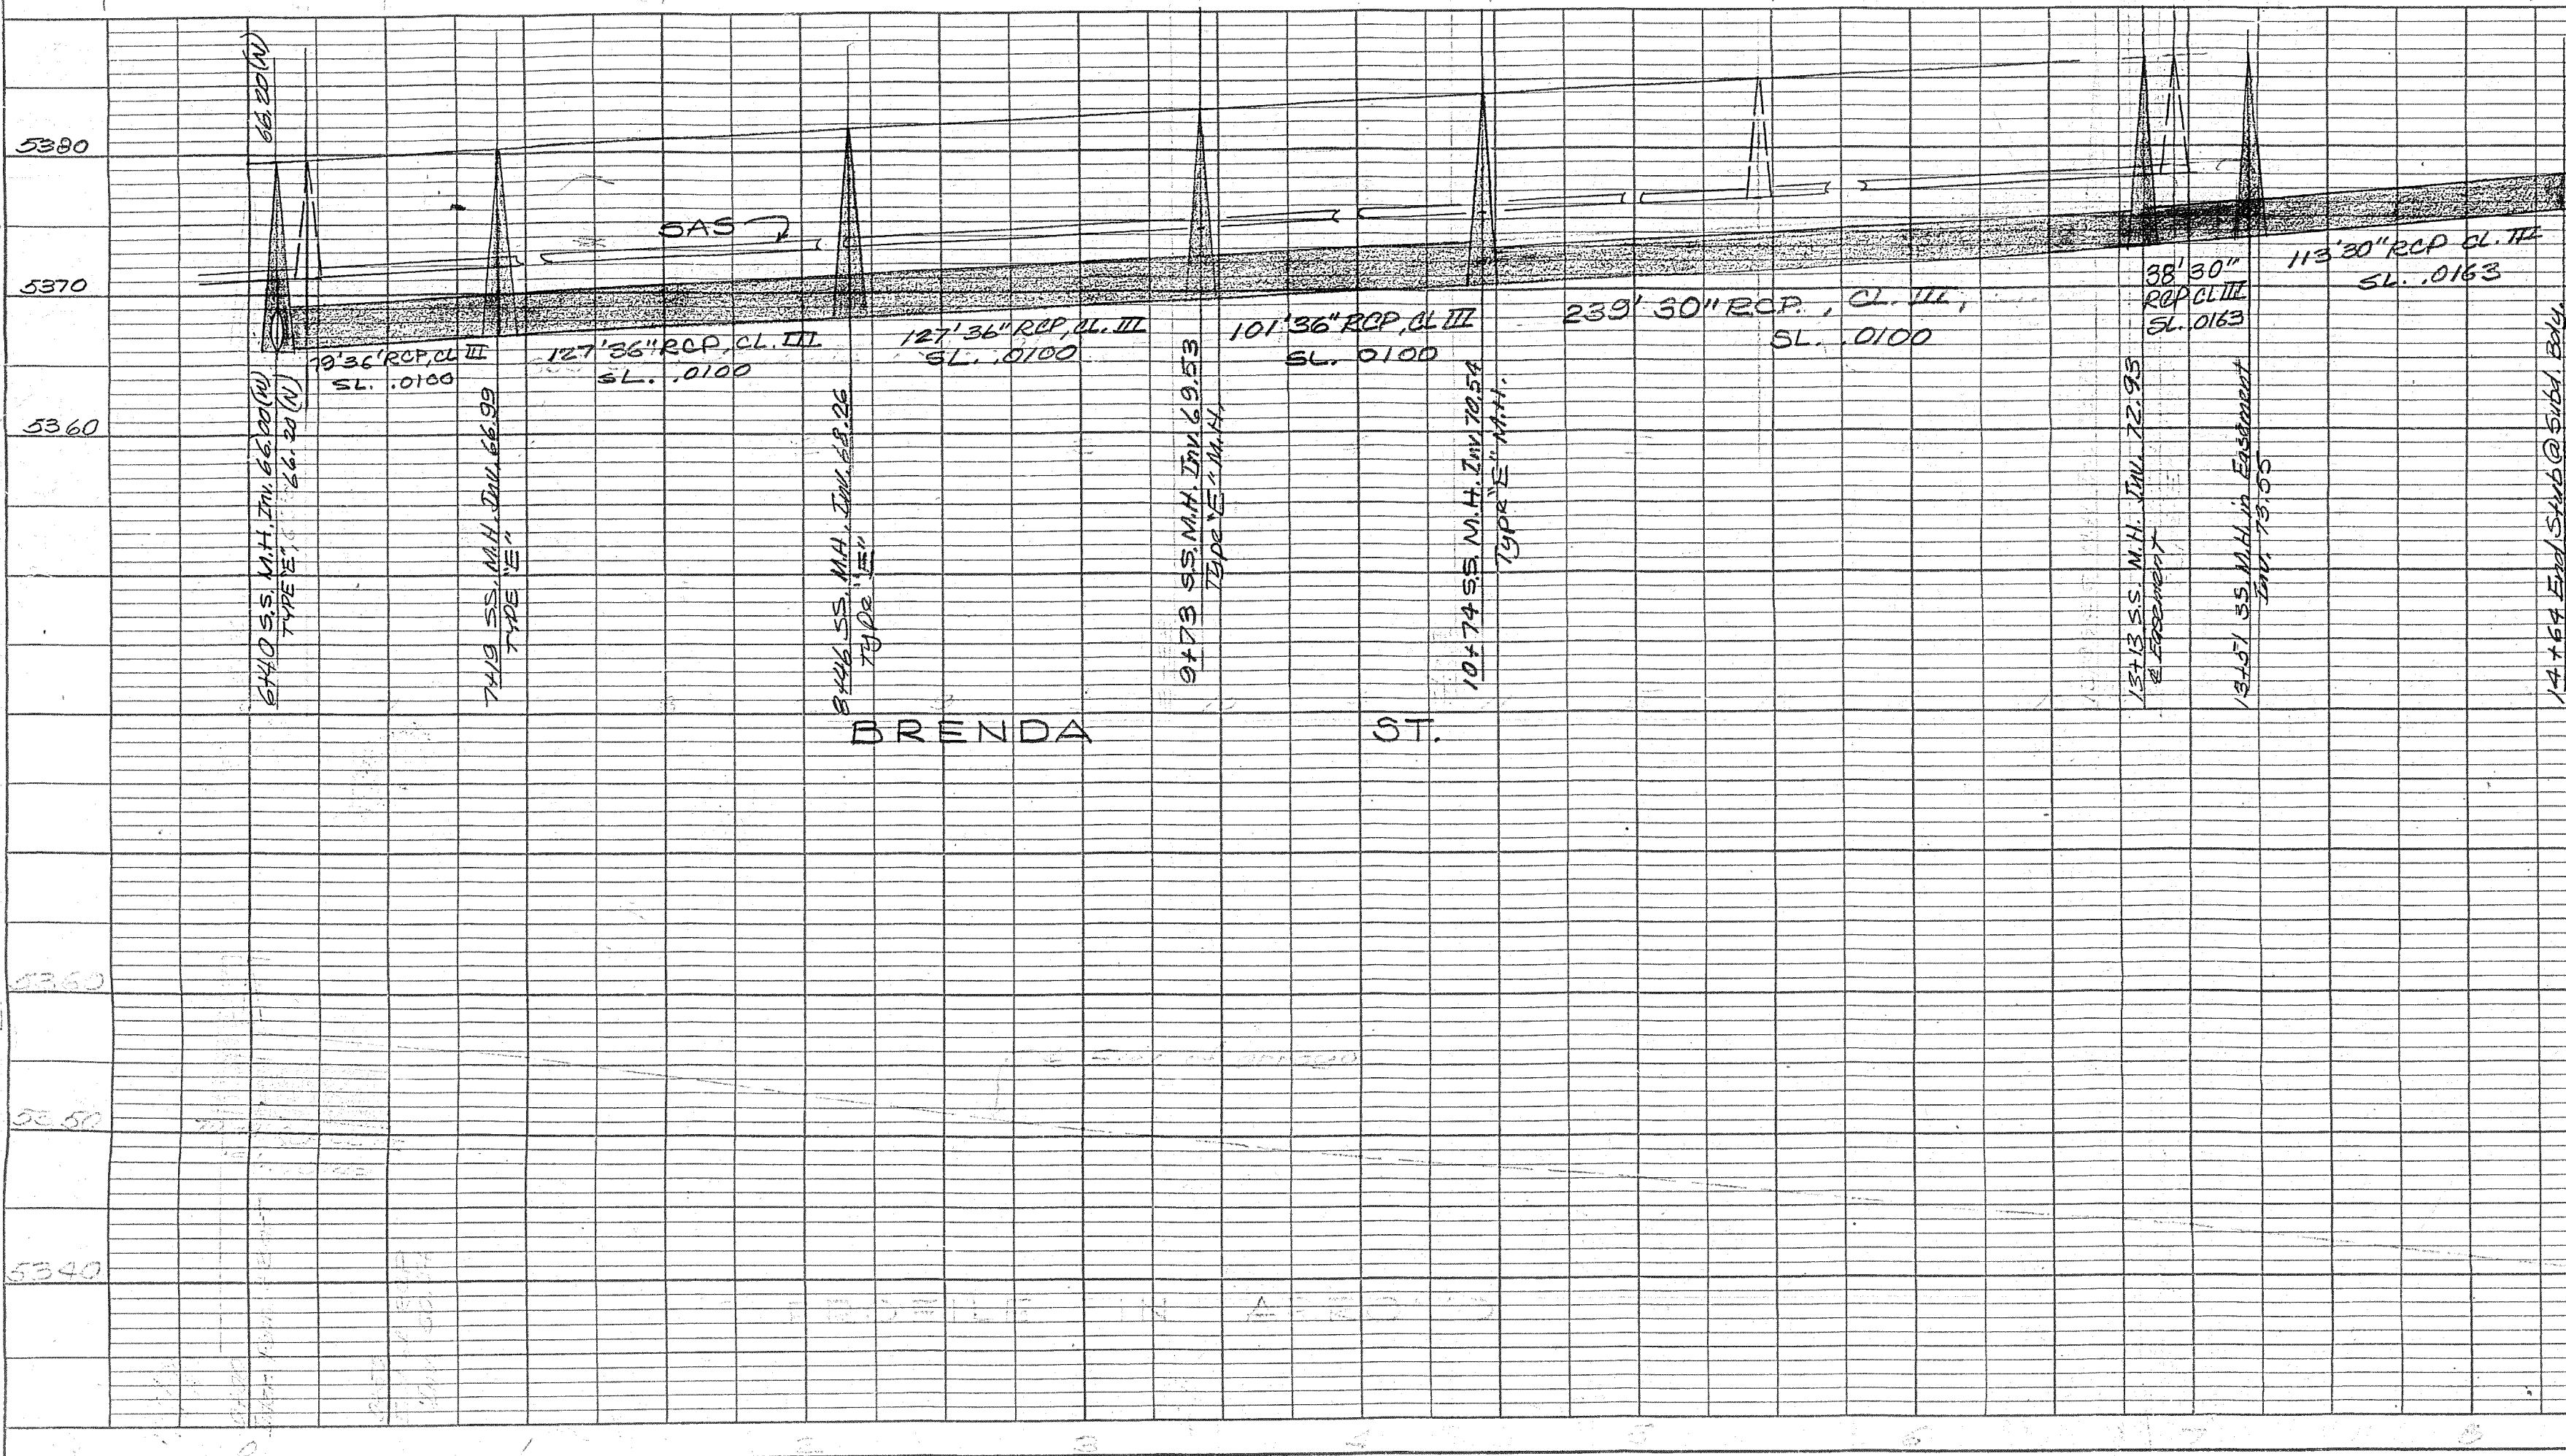

35-16-71
Map No. E-19-5

CITY OF ALBUQUERQUE PUBLIC WORKS DEPARTMENT ENGINEERING DIVISION			
TITLE STORM SEWER - MONTEREY EAST ADD AND PARK III ADD.			
SUBMITTED BY	APPROVED BY	PRELIMINARY DRWG.	
DATE	DATE	DATE	
DESIGNED BY	APPROVED BY	CONSTRUCTION DRWG.	
DATE	DATE	DATE	
DRAWN BY	APPROVED BY	AS BUILT DRWG.	
DATE	DATE	DATE	
CHECKED BY	APPROVED BY	FILE NO.	
DATE	DATE	DATE	
REV. BY	NOTES	35-16-71	
DATE	NOTES	SHEET NO.	
REV. BY	NOTES	2	
DATE	NOTES		