

LIST OF DRAWINGS


SHEET	TITLE
1	STORM SEWER - SECOND STREET.
2	STORM SEWER - ROMA AVENUE.
3	SANITARY SEWER - SECOND STREET
4	SANITARY SEWER - ROMA AVENUE SHEET 1
5	SANITARY SEWER - ROMA AVENUE SHEET 2

NOTES


- Manholes shall be City of Albuquerque Standard, Type and Size as indicated.
- Concrete for curbs and gutters shall have a compressive strength of 3000 psi at 28 days.
- Where curbs and sidewalks are cut, remove the entire width to the nearest joint.
- Bench mark** on sidewalk at NE corner of 4th street and Roma Ave. Elev. 4954.03.
- Contractor shall restore all pavement, curb and gutter and sidewalks removed or damaged by his operations.
- Two lanes of traffic must be maintained on 2nd, 3rd and 4th streets, Roma Ave and Marquette Ave.
- Traffic Engineer to arrange with Public Service Co. of N.M. for removal and replacement of street lighting standards (poles).

LEGEND

- ⊙ Sanitary Sewer Manhole
- ⊕ Storm Sewer Manhole
- Street Light
- ⊕ Electric Manhole
- W- Water Line
- G- Gas Line
- S- Sanitary Sewer
- SS- Storm Sewer
- ⚡ Fire Hydrant

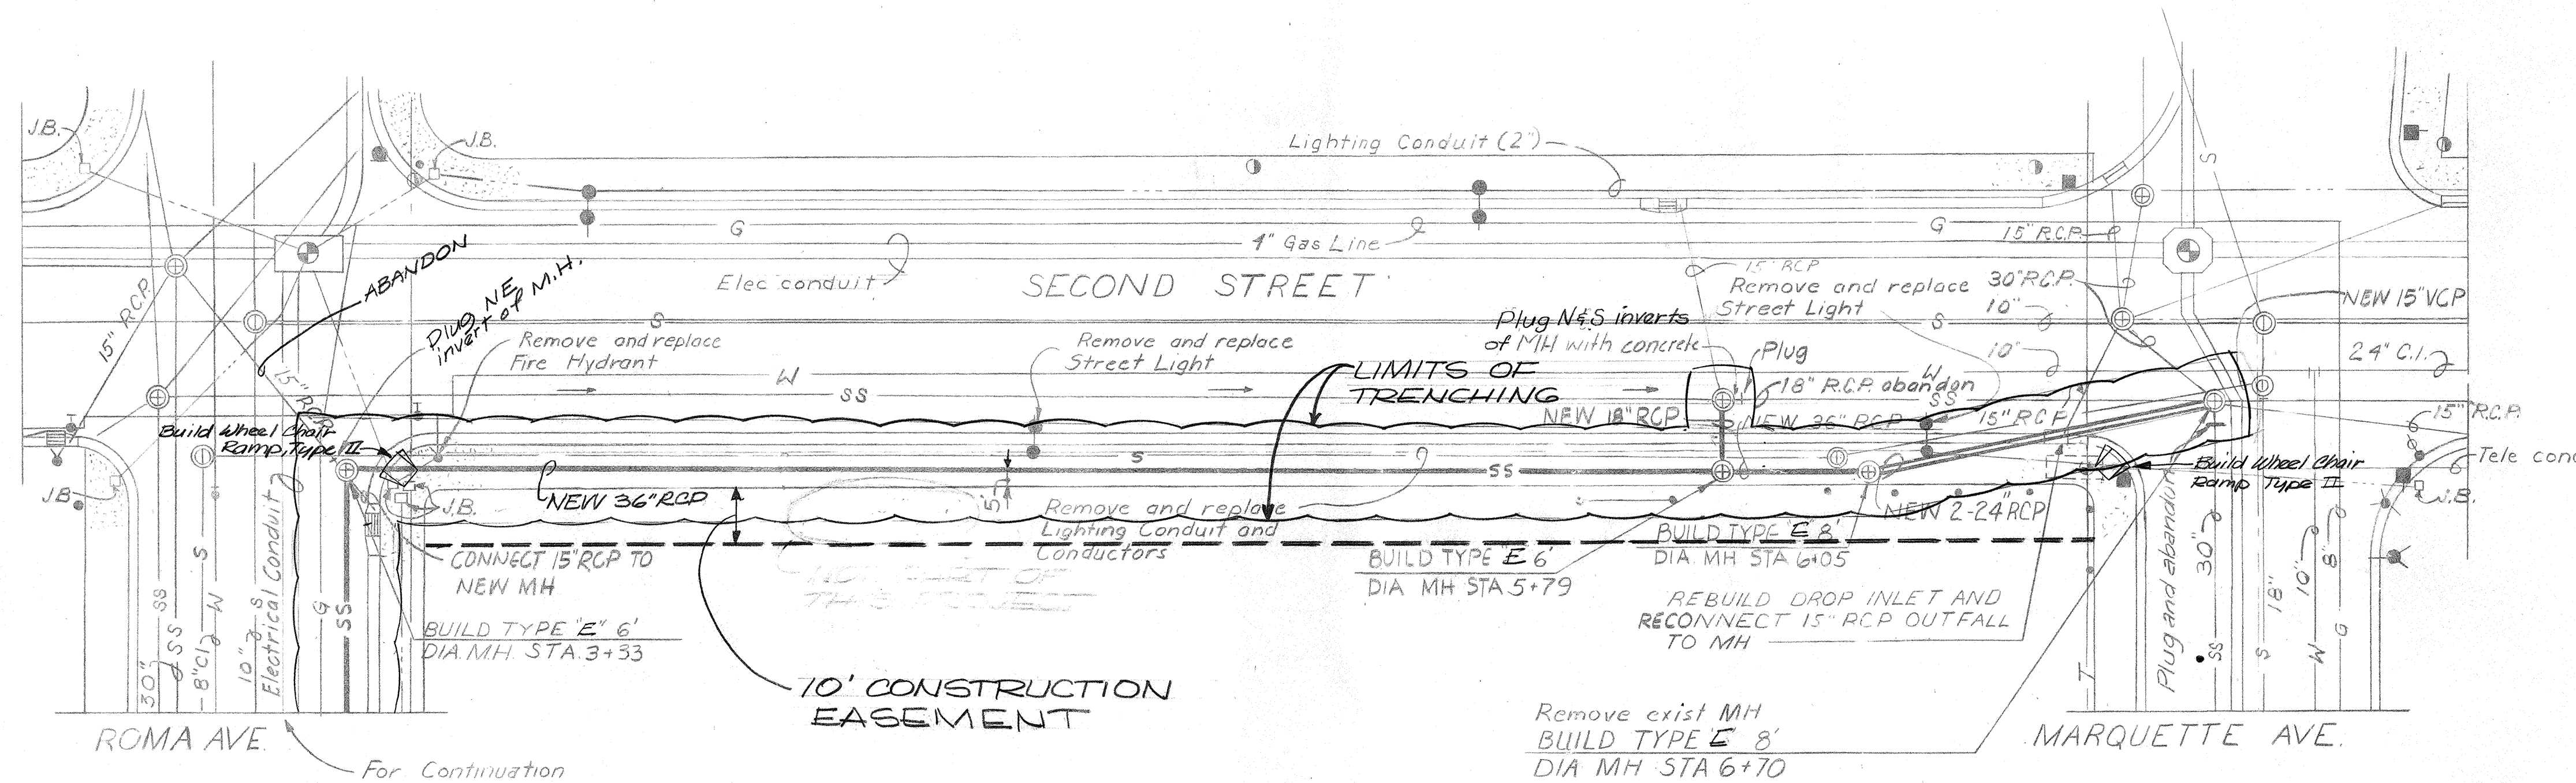

PLAN
Scale: 1" = 20'

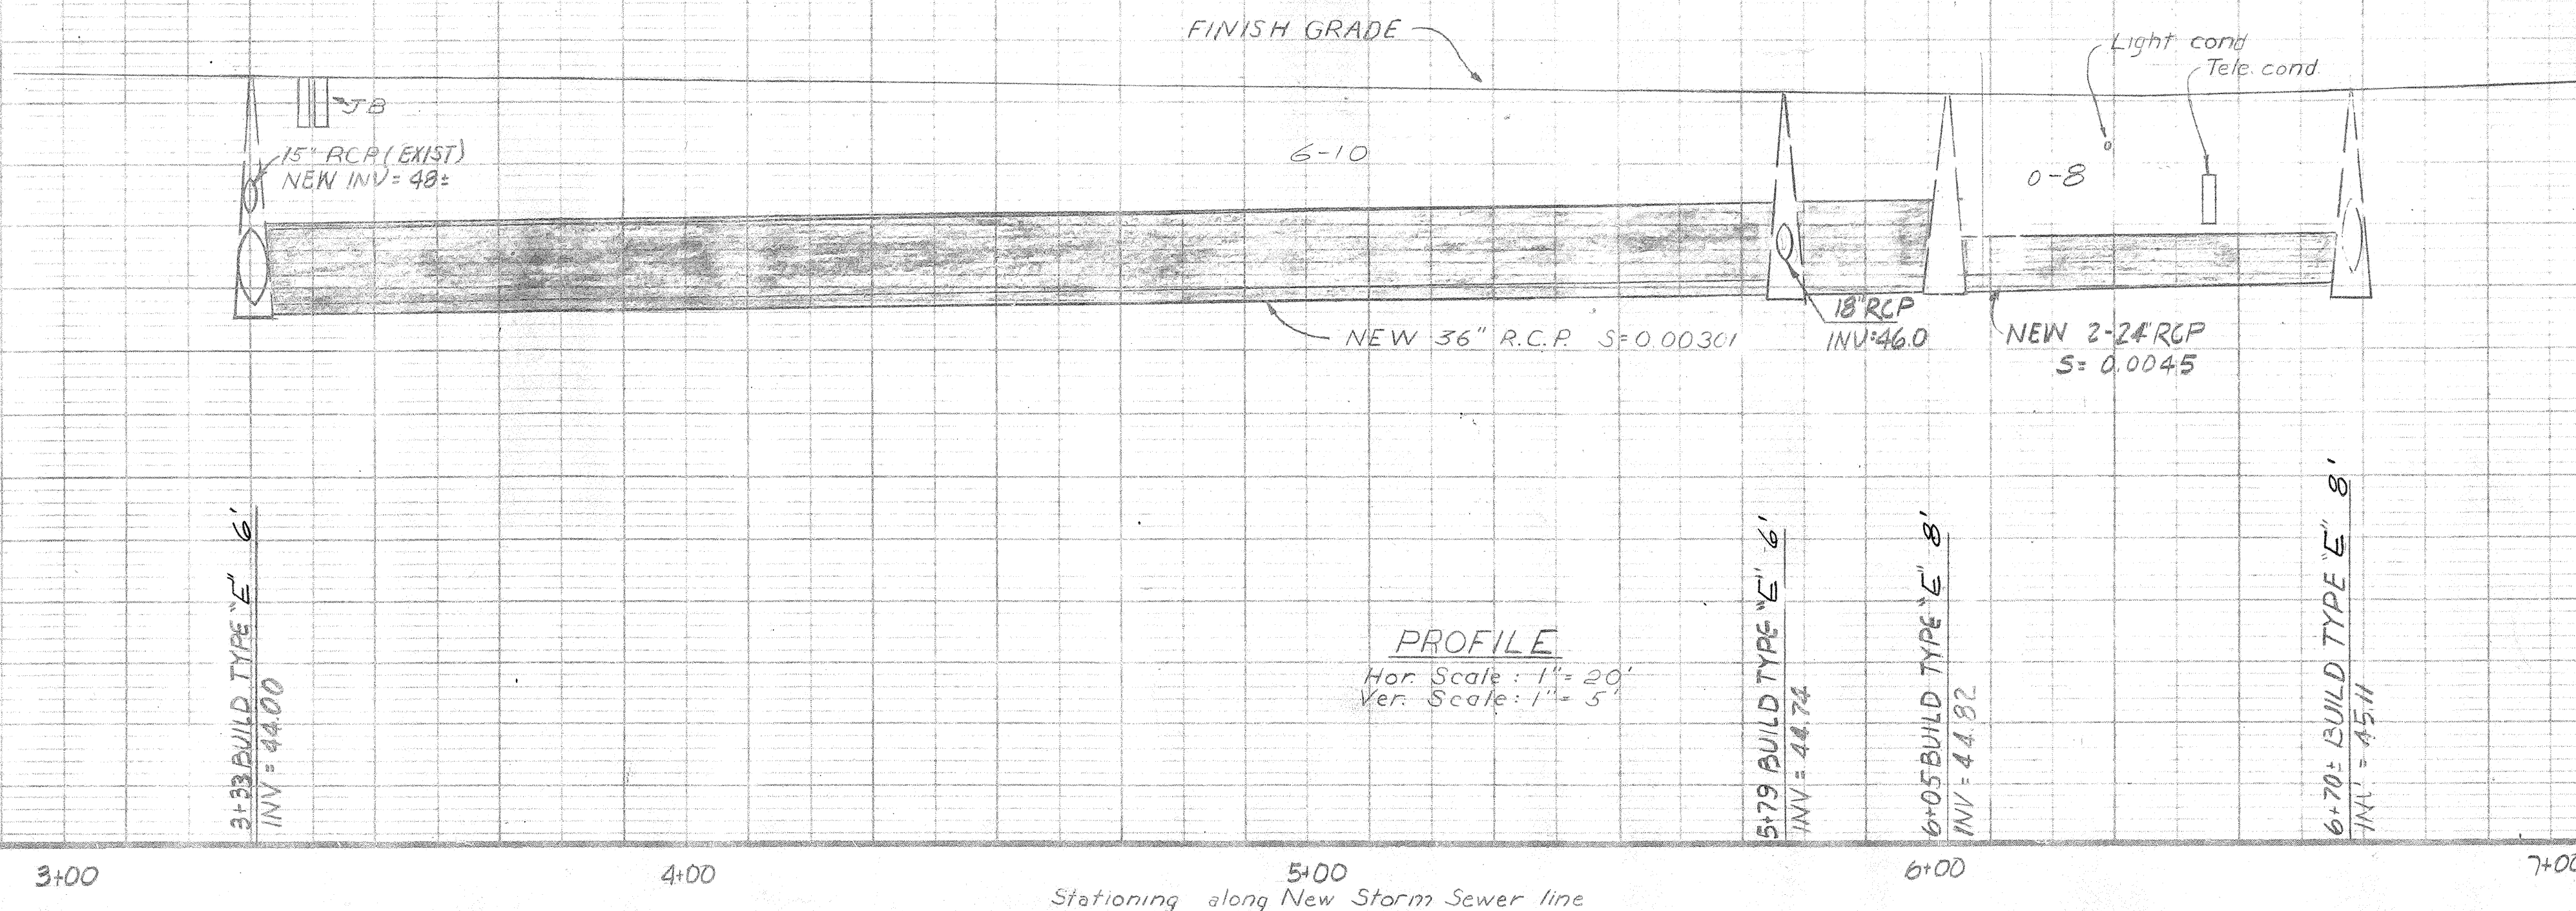

PROFILE
Hor. Scale: 1" = 20'
Ver. Scale: 1" = 5'


1	2	3	4	5	6	7	8	9	10	11	12	13	14	15	16	17	18	19	20	21	22	23	24	25	26	27	28	29	30	31
22	007	017	5																											

MAP NO. J-14-S

NO.	DATE	REMARKS	RECORDED BY
REVISIONS			
CITY OF ALBUQUERQUE PUBLIC WORKS DEPARTMENT ENGINEERING DIVISION			
LE ROMA & SECOND FROM THIRD TO MARQUETTE - STORM SEWER			
DESIGNED BY	DRAWN BY	AS BUILT	
TITLE	TITLE	SUBMITTED BY	
DATE	DATE	TITLE	
APPROVAL			
ASS'T CITY ENGINEER	CITY ENGINEER	RECORDED BY	
DATE	DATE	TITLE	
WATER ENGINEER	LIQUID WASTE ENGINEER	SHEET NO.	2 OF 2
DATE	DATE	SHEETS	
DRAWING NUMBER			

REVISION	DATE	DESCRIPTION	BY	APPRO
SVERDRUP & PARCEL AND ASSOCIATES, INC. ENGINEERS - ARCHITECTS SAN FRANCISCO, CALIFORNIA				
UTILITIES - RELOCATION CITY OF ALBUQUERQUE STORM SEWER - SECOND STREET PLAN AND PROFILE				
SCALE	AS SHOWN	SUBMITTED	DATE	7-29-74
DESIGNED	J V H	APPROVED	DRAWING NO.	FPI 7401-10
DRAWN	CWC	APPROVED	SHEET 1	
CHECKED	WWS			


BENCH MARK: ON SIDEWALK AT N.E. CORNER
OF 4th STREET AND ROMA AVE.
ELEV. 4954.03.

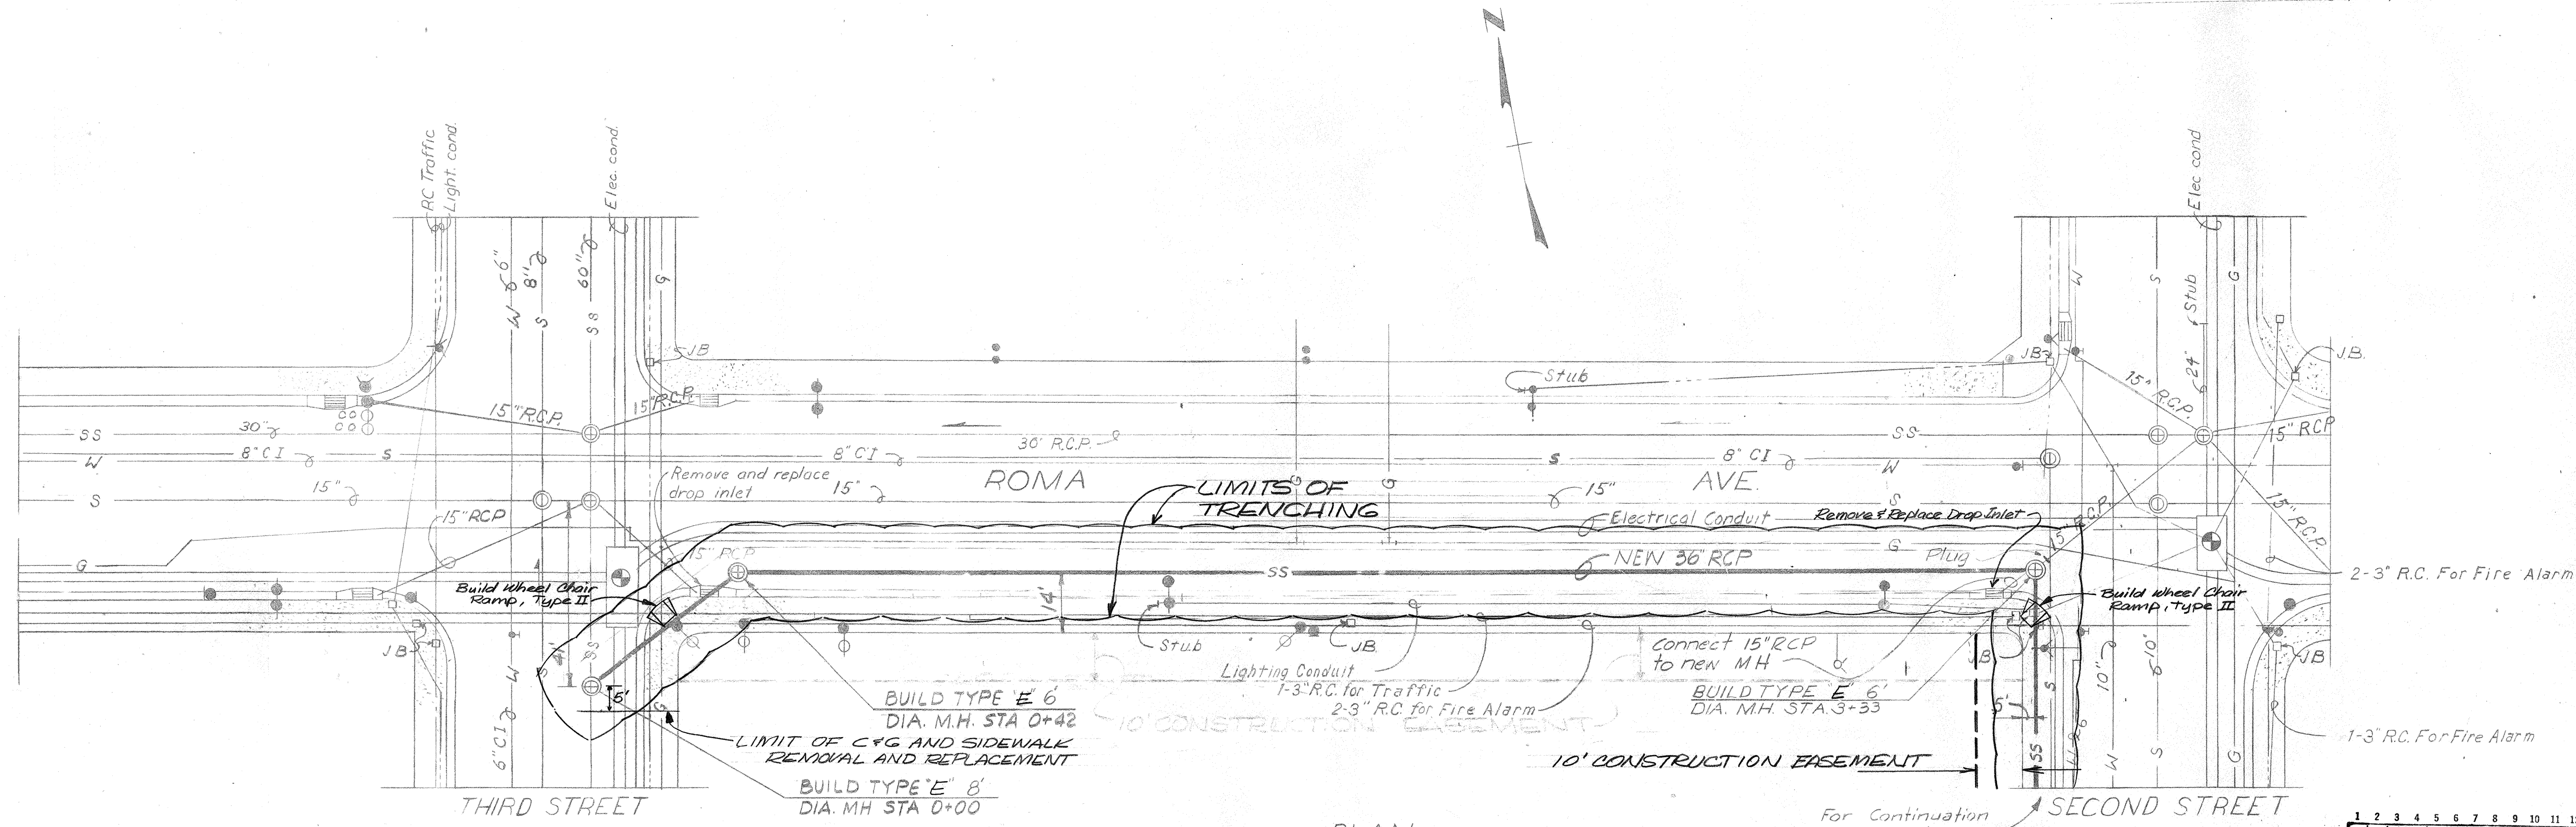

PLAN
Scale: 1"=20'

For Continuation
See Sheet 1

1	2	3	4	5	6	7	8	9	10	11	12	13	14	15	16	17	18	19	20	21	22	23	24	25	26	27	28	29	30	31	
22	007	027	5						01																581	4	✓				

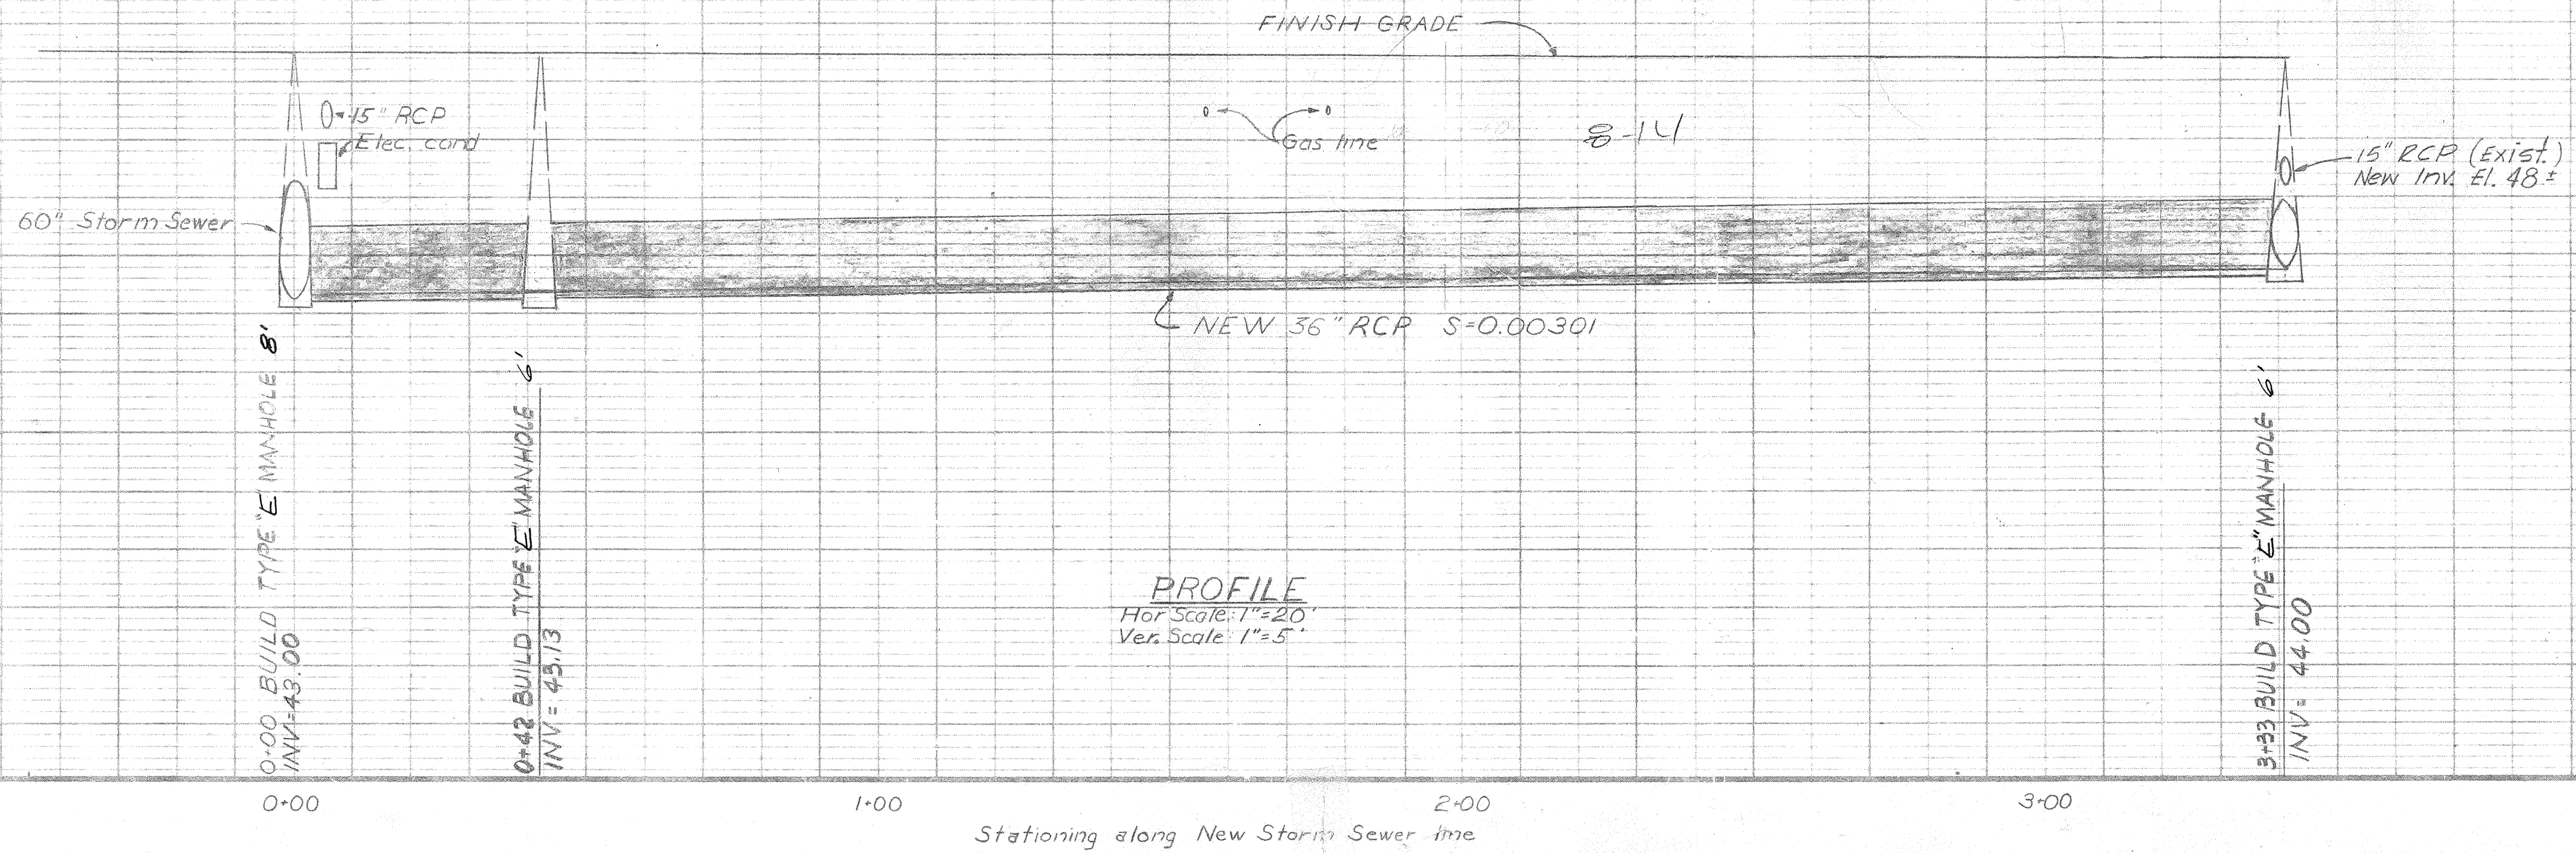

PROFILE
Hor Scale: 1"=20'
Ver. Scale: 1"=5'

MAP NO. U-14, S			
NO.	DATE	REMARKS	RECORDED BY
CITY OF ALBUQUERQUE PUBLIC WORKS DEPARTMENT ENGINEERING DIVISION			
TITLE ROMA & SECOND FROM THIRD TO MARQUETTE - STORM SEWER DESIGN			
DESIGNED BY	DRAWN BY	AS BUILT	
TITLE	TITLE	SUBMITTED BY	
DATE	DATE	DATE	
APPROVAL		RECORDED BY	
ASS'T CITY ENGINEER	CITY ENGINEER	TITLE	
DATE	DATE	DATE	
WATER ENGINEER	LIQUID WASTE ENGINEER	SHEET NO.	
DATE	DATE	SHEETS	
DRAWING NUMBER			
SVERDRUP & PARCEL AND ASSOCIATES, INC. ENGINEERS - ARCHITECTS SAN FRANCISCO, CALIFORNIA			
UTILITIES RELOCATION CITY OF ALBUQUERQUE STORM SEWER - ROMA AVE. PLAN AND PROFILE			
SCALE AS SHOWN	SUBMITTED	DATE 7-29-74	
DESIGNED JVIH	SVERDRUP & PARCEL AND ASSOCIATES, INC.	DRAWING NO.	
DRAWN CWC	APPROVED	FPI 7401-10	
CHECKED WWS		SHEET 2	