


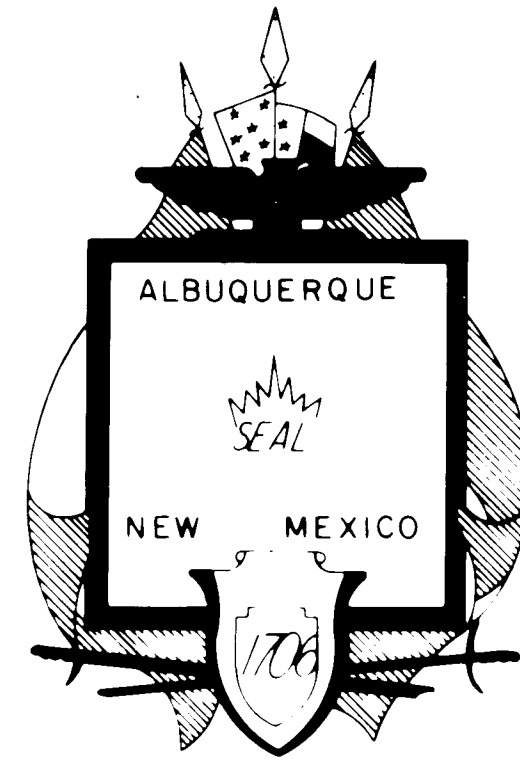


CITY OF ALBUQUERQUE, NEW MEXICO

CONSTRUCTION PLANS FOR ACADEMY SQUARE UNIT ONE PHASE IV

INDEX

SHEET No.	DESCRIPTION
1.	TITLE and INDEX SHEET
2.	GENERAL NOTES and LEGEND
3.	PLAT
4.	GRADING PLAN AND DETAILS
5.	WATER and SANITARY SEWER LAYOUT w/ PLAN and PROFILE INDEX
6-7.	PLAN and PROFILE SHEETS
8.	STREET SECTIONS and DETAILS

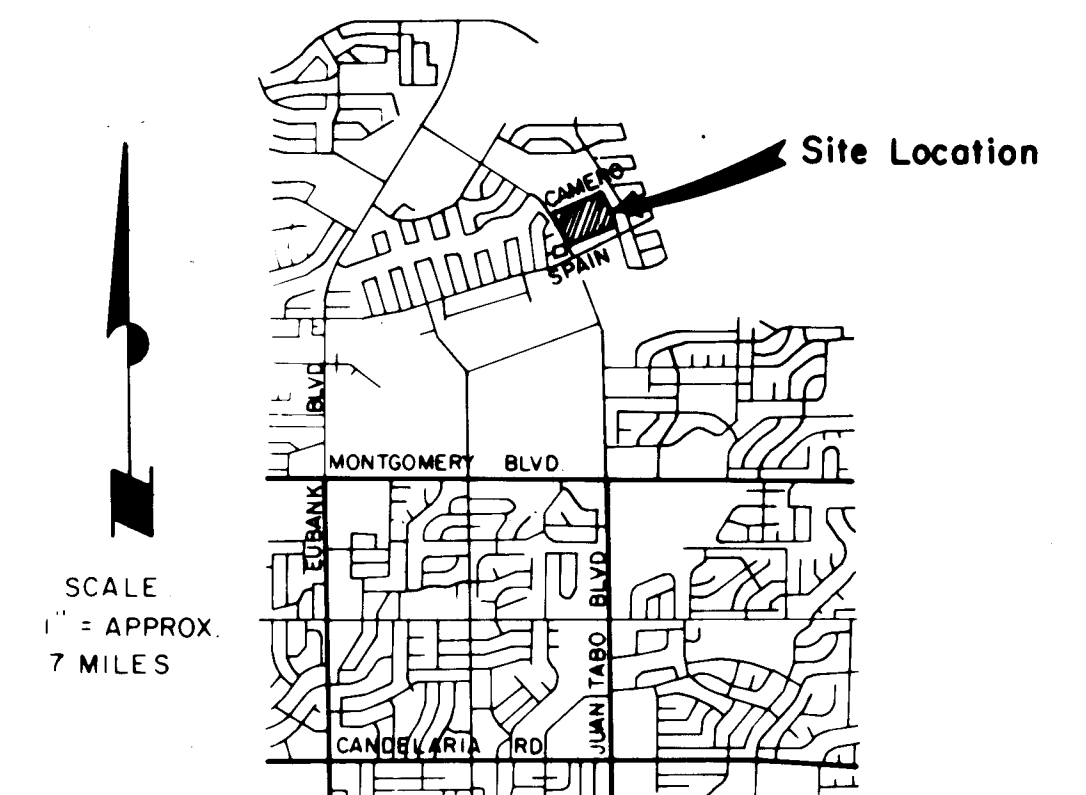

LOCATION MAP
ZONE ATLAS MAP No F-21



DENNEY-GROSS & ASSOCIATES, INC.
ENGINEERS-PLANNERS
ALBUQUERQUE, NEW MEXICO 87107

W.F. McHanna
7-16-85

REV.	SHEETS	CITY ENGR.	DATE	USER DEPT.	DATE	USER DEPT.	DATE
APPROVAL OF REVISIONS							





DENNEY-GROSS & ASSOC., INC.
ENGINEERS SURVEYORS PLANNERS
2400 COMANCHE RD. N.E., ALBUQ. N.M. 87107
(505) 884-0696





APPROVED FOR
CONSTRUCTION
[Signature]
9/19/87 C.E.

DWG. No. 2209

SHEET 1 OF 8

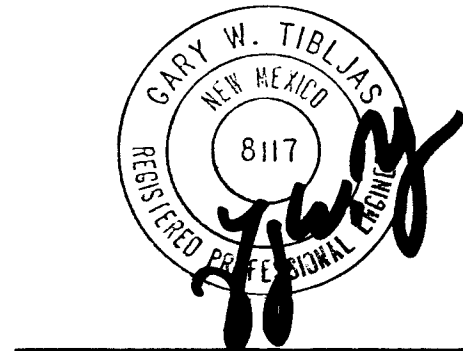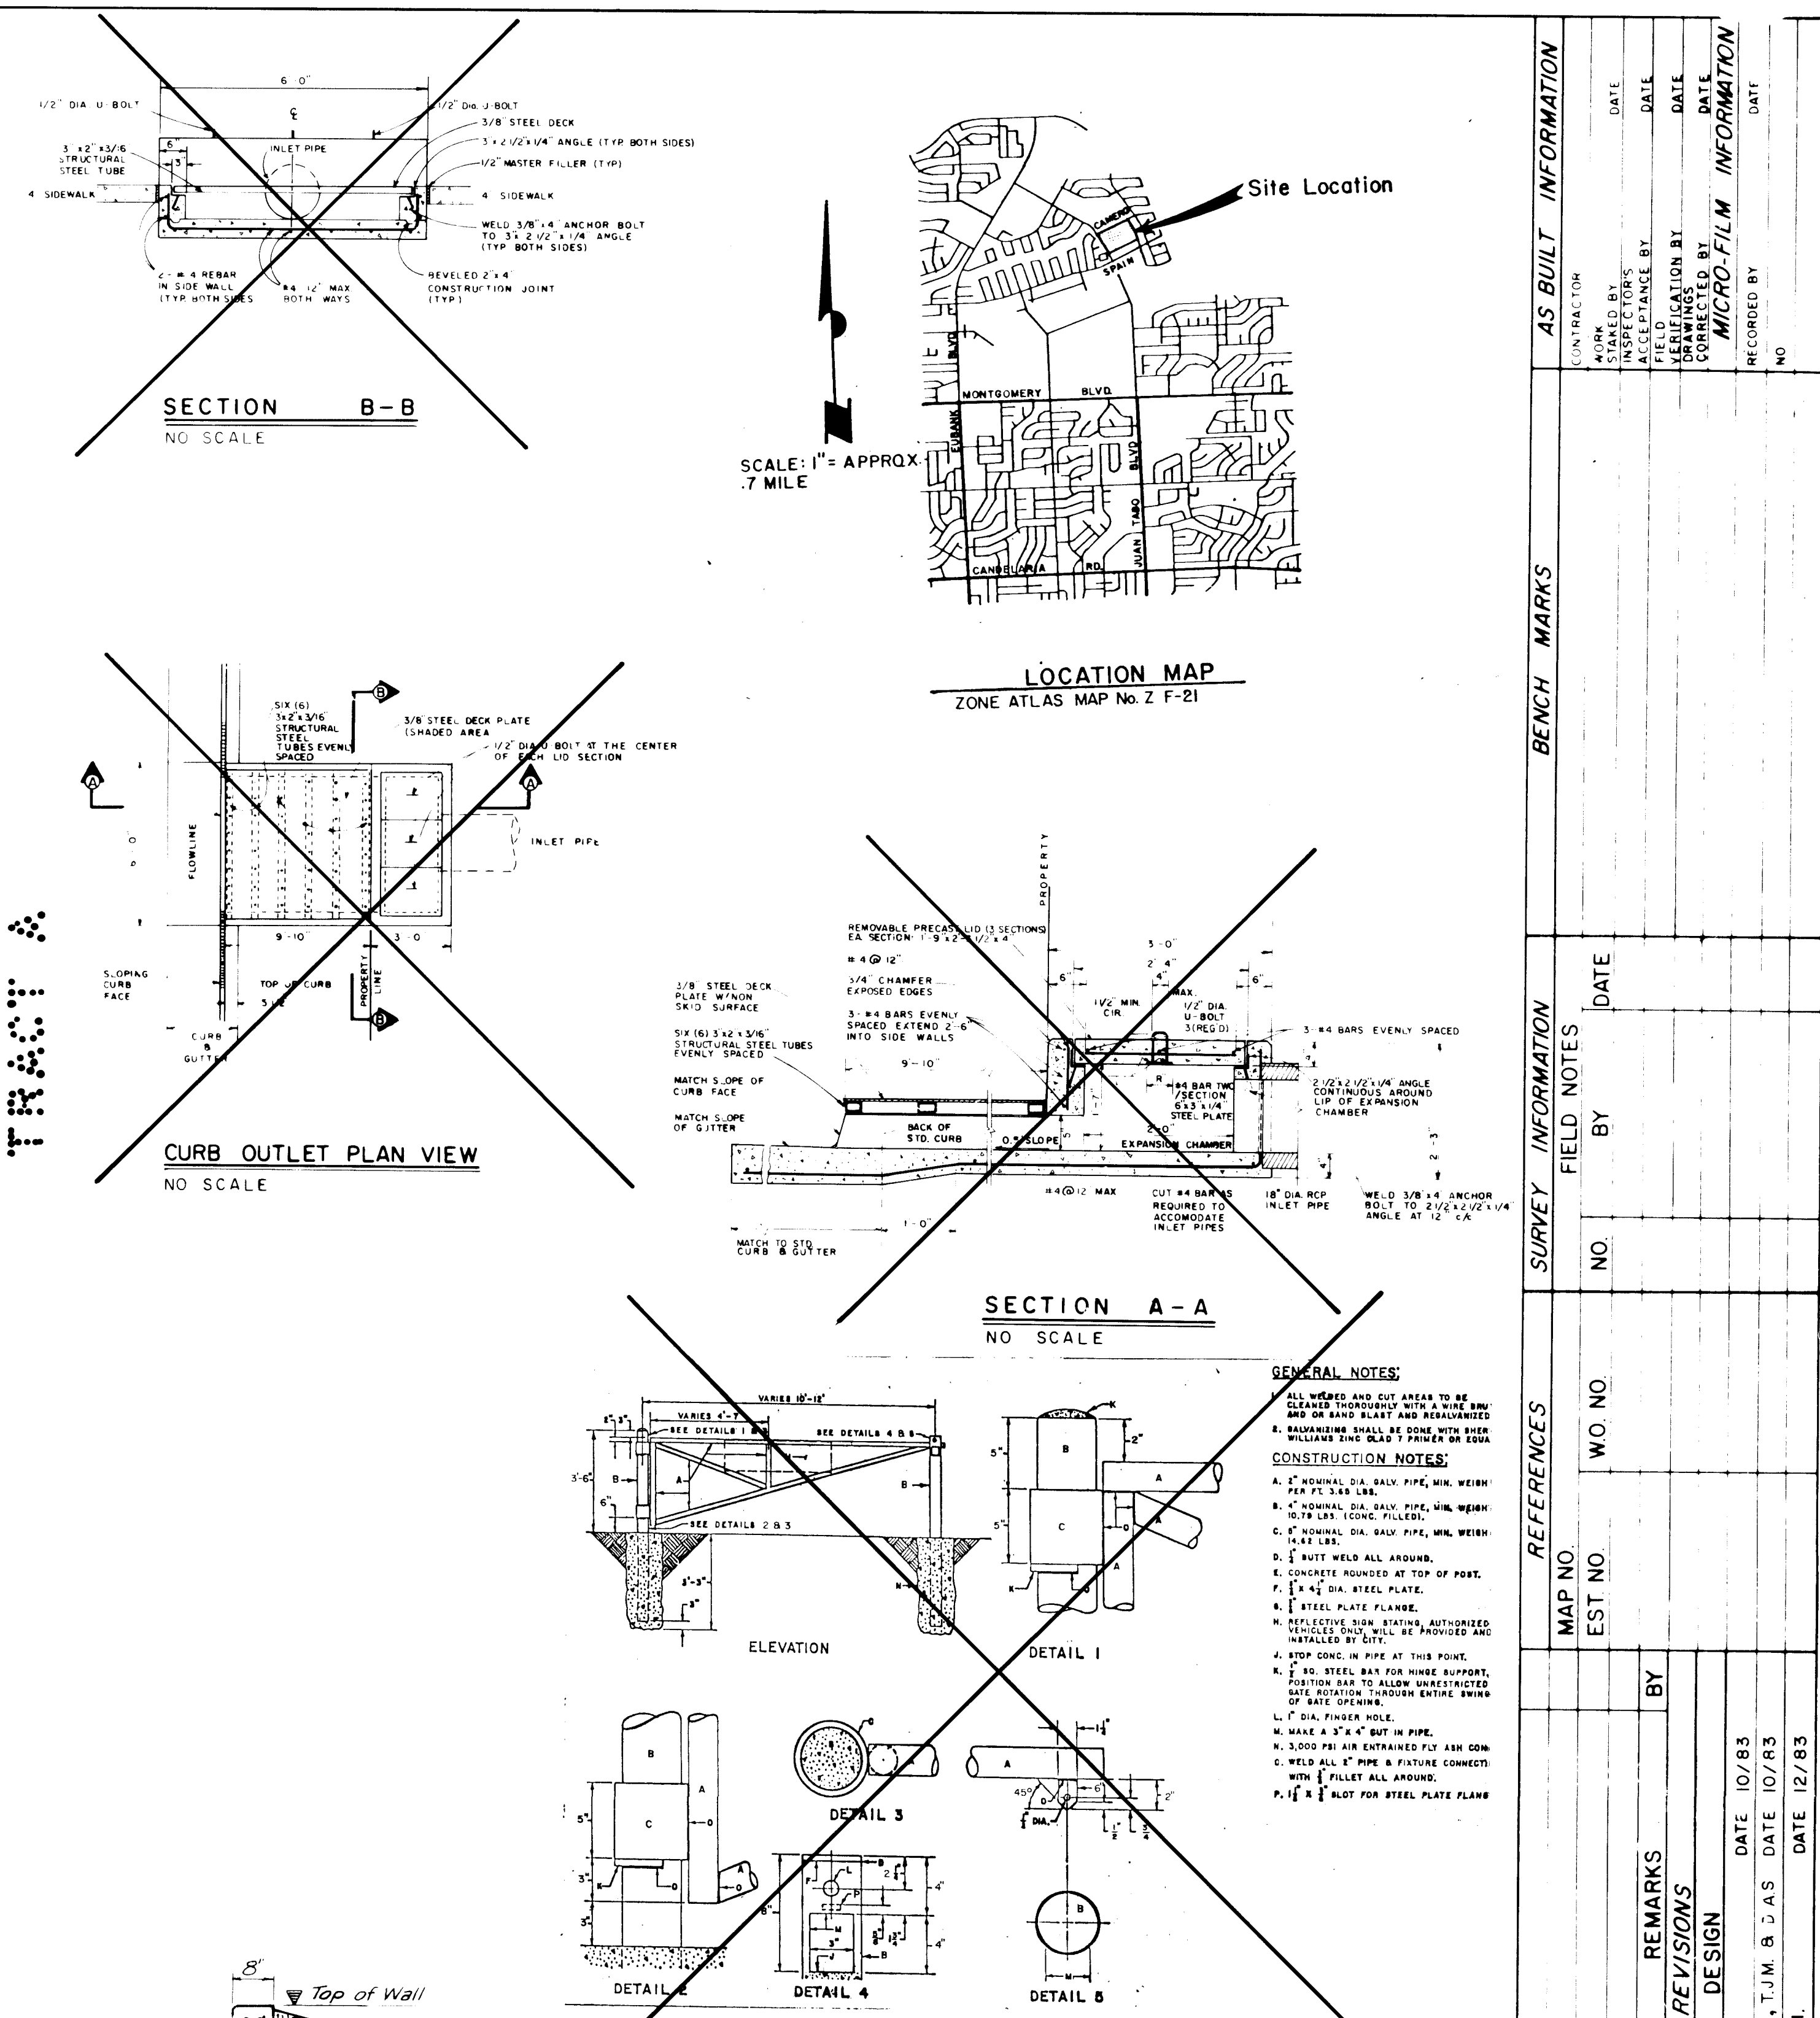

D.G.A JOB NO. 646.32

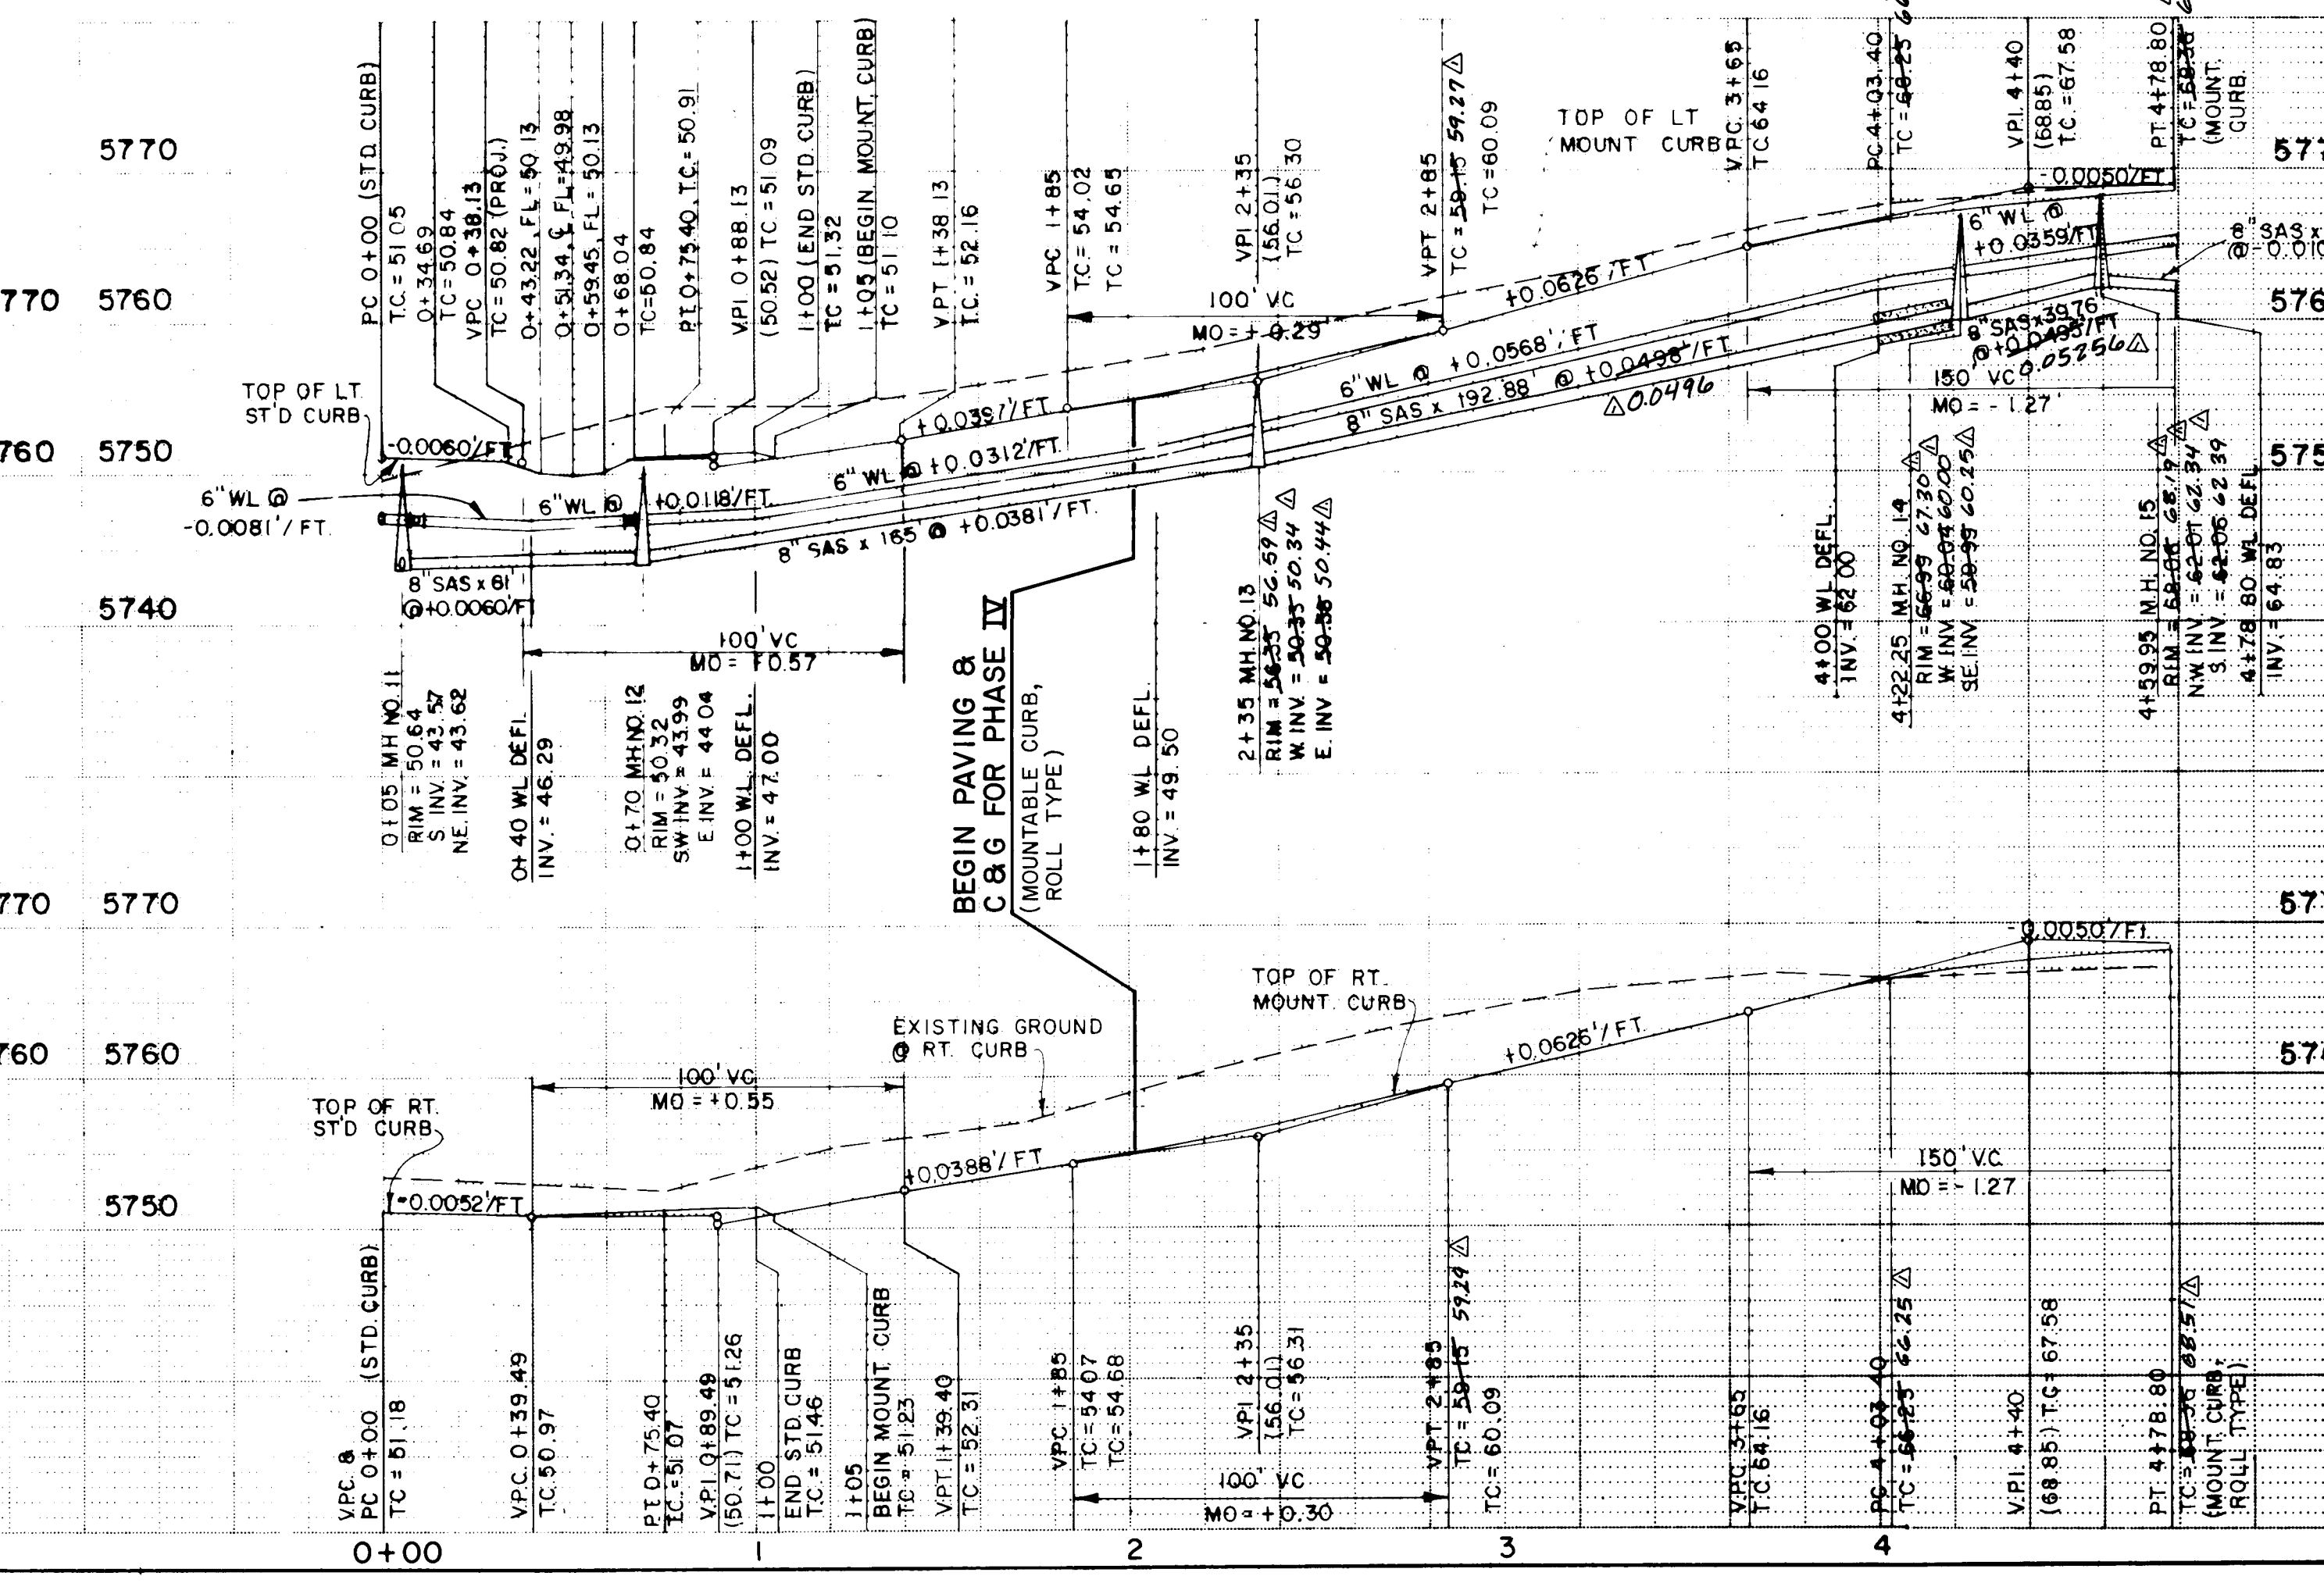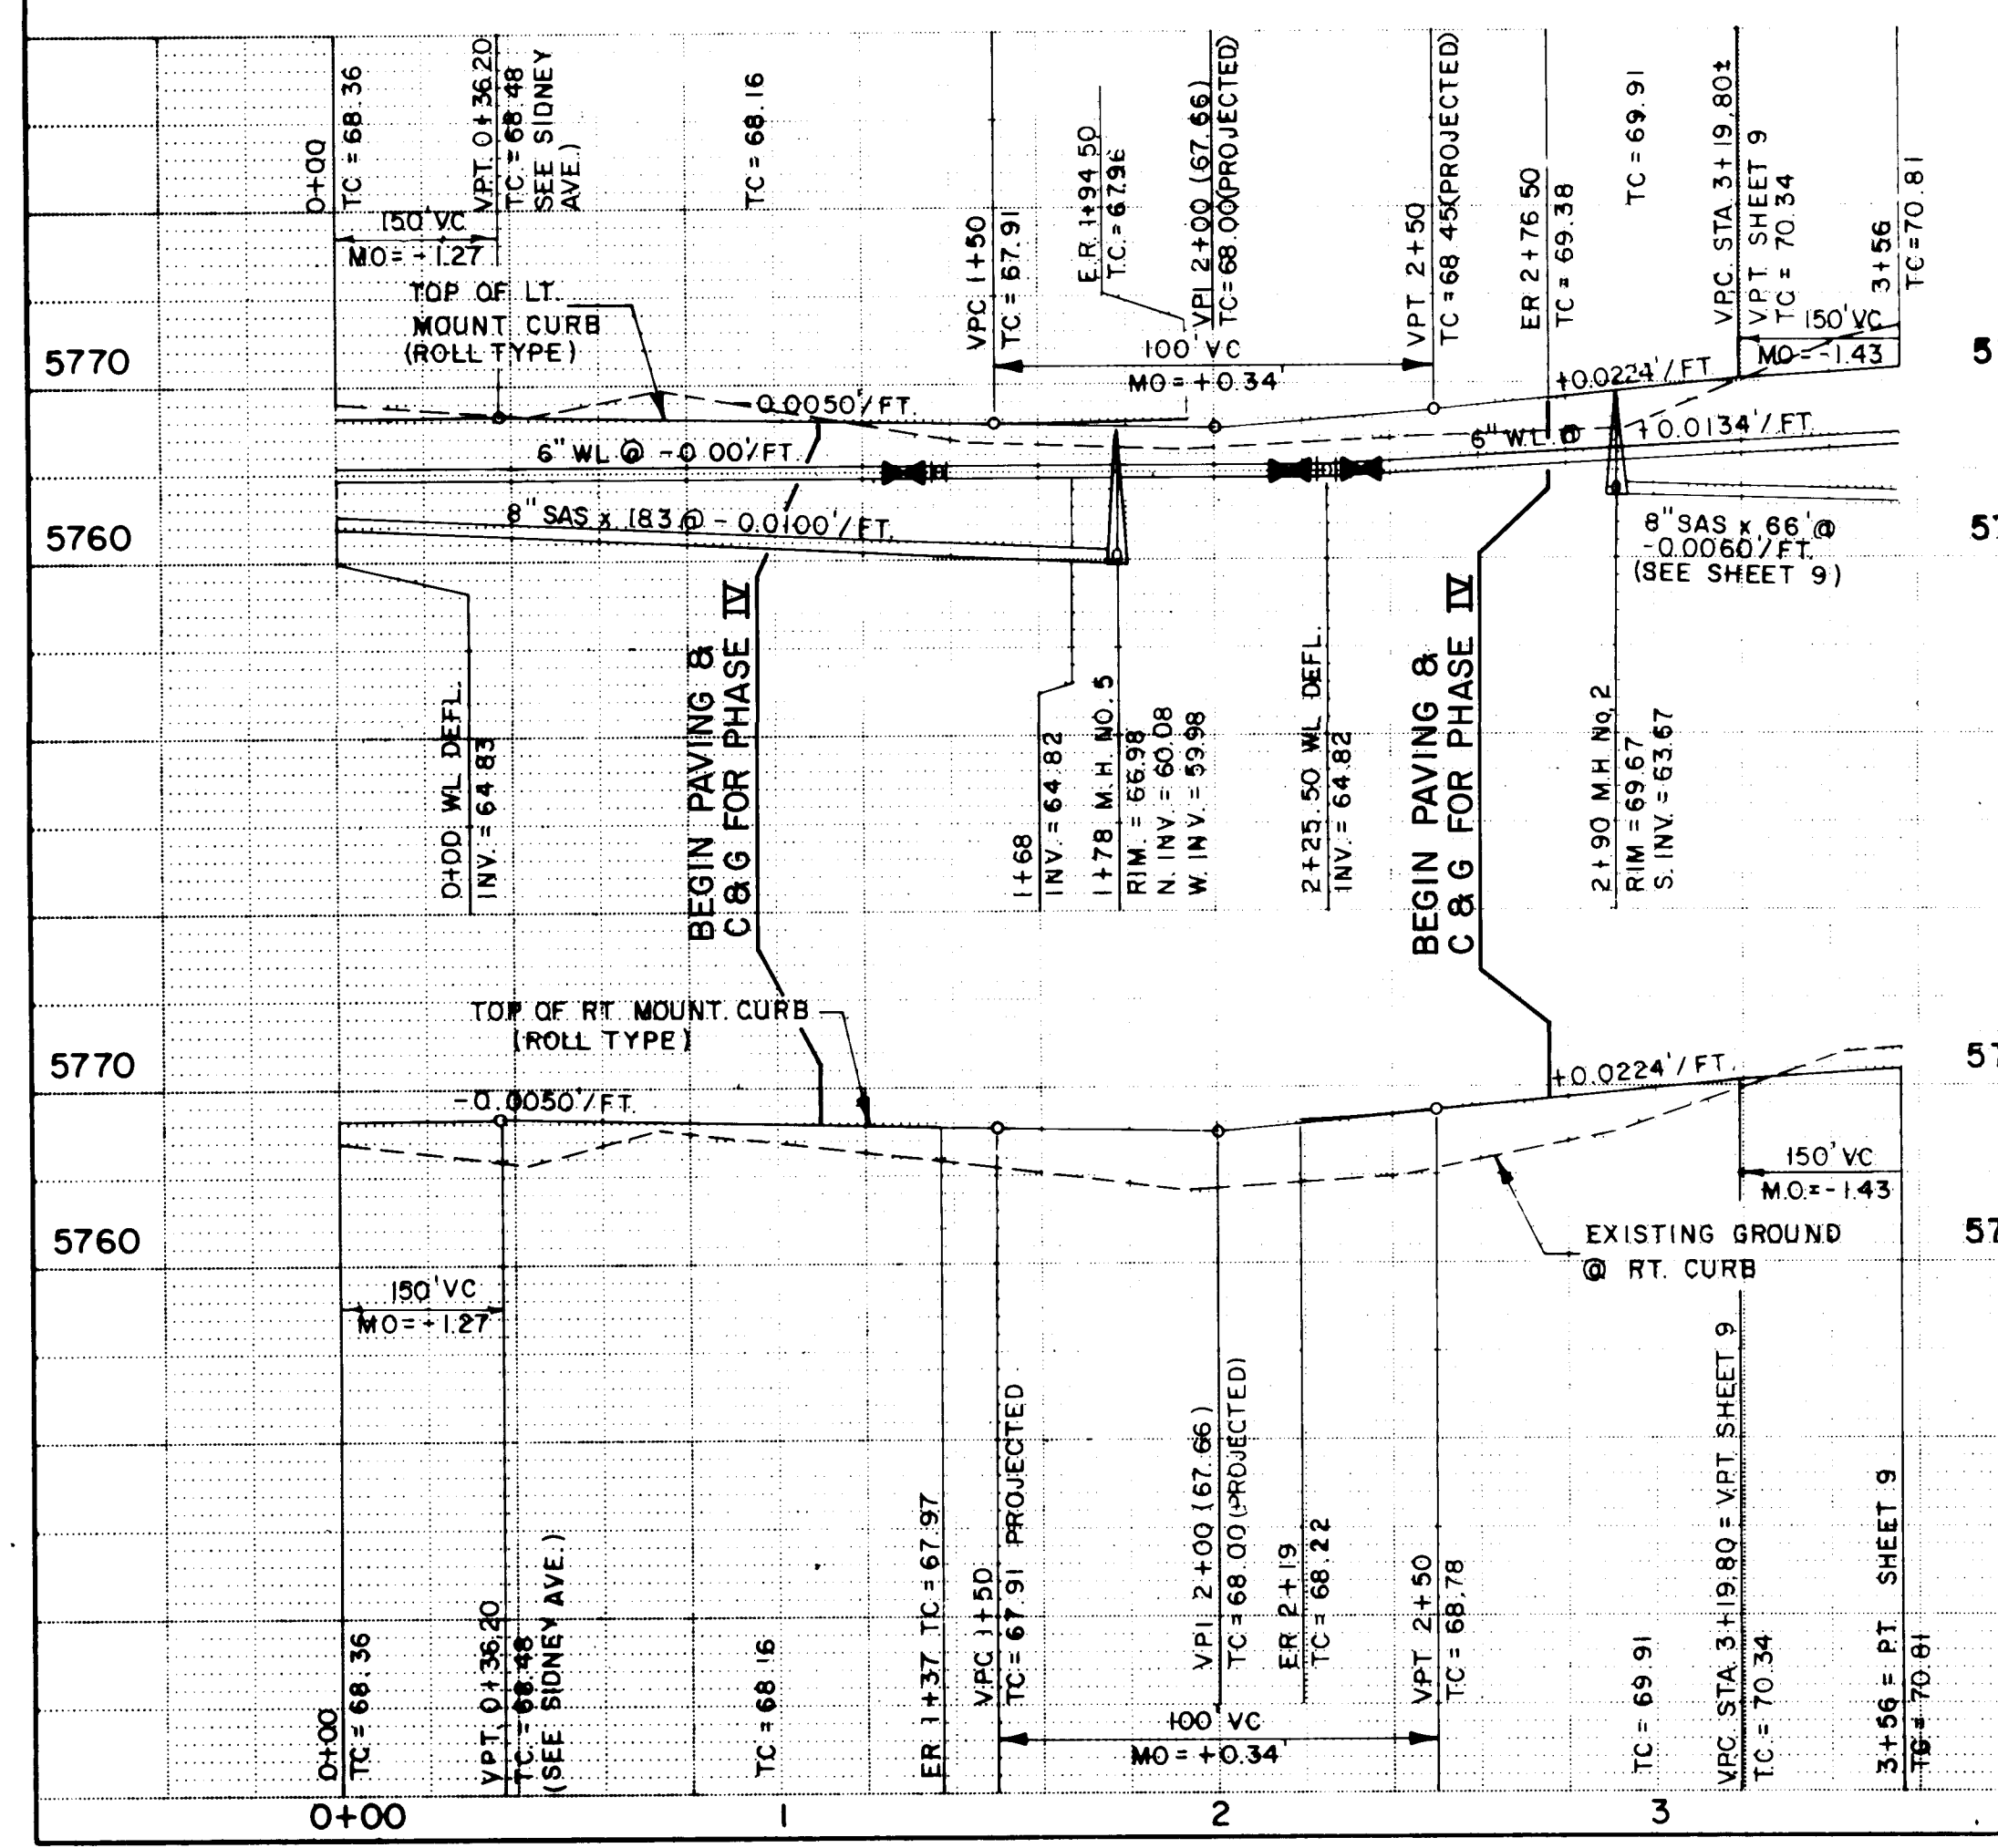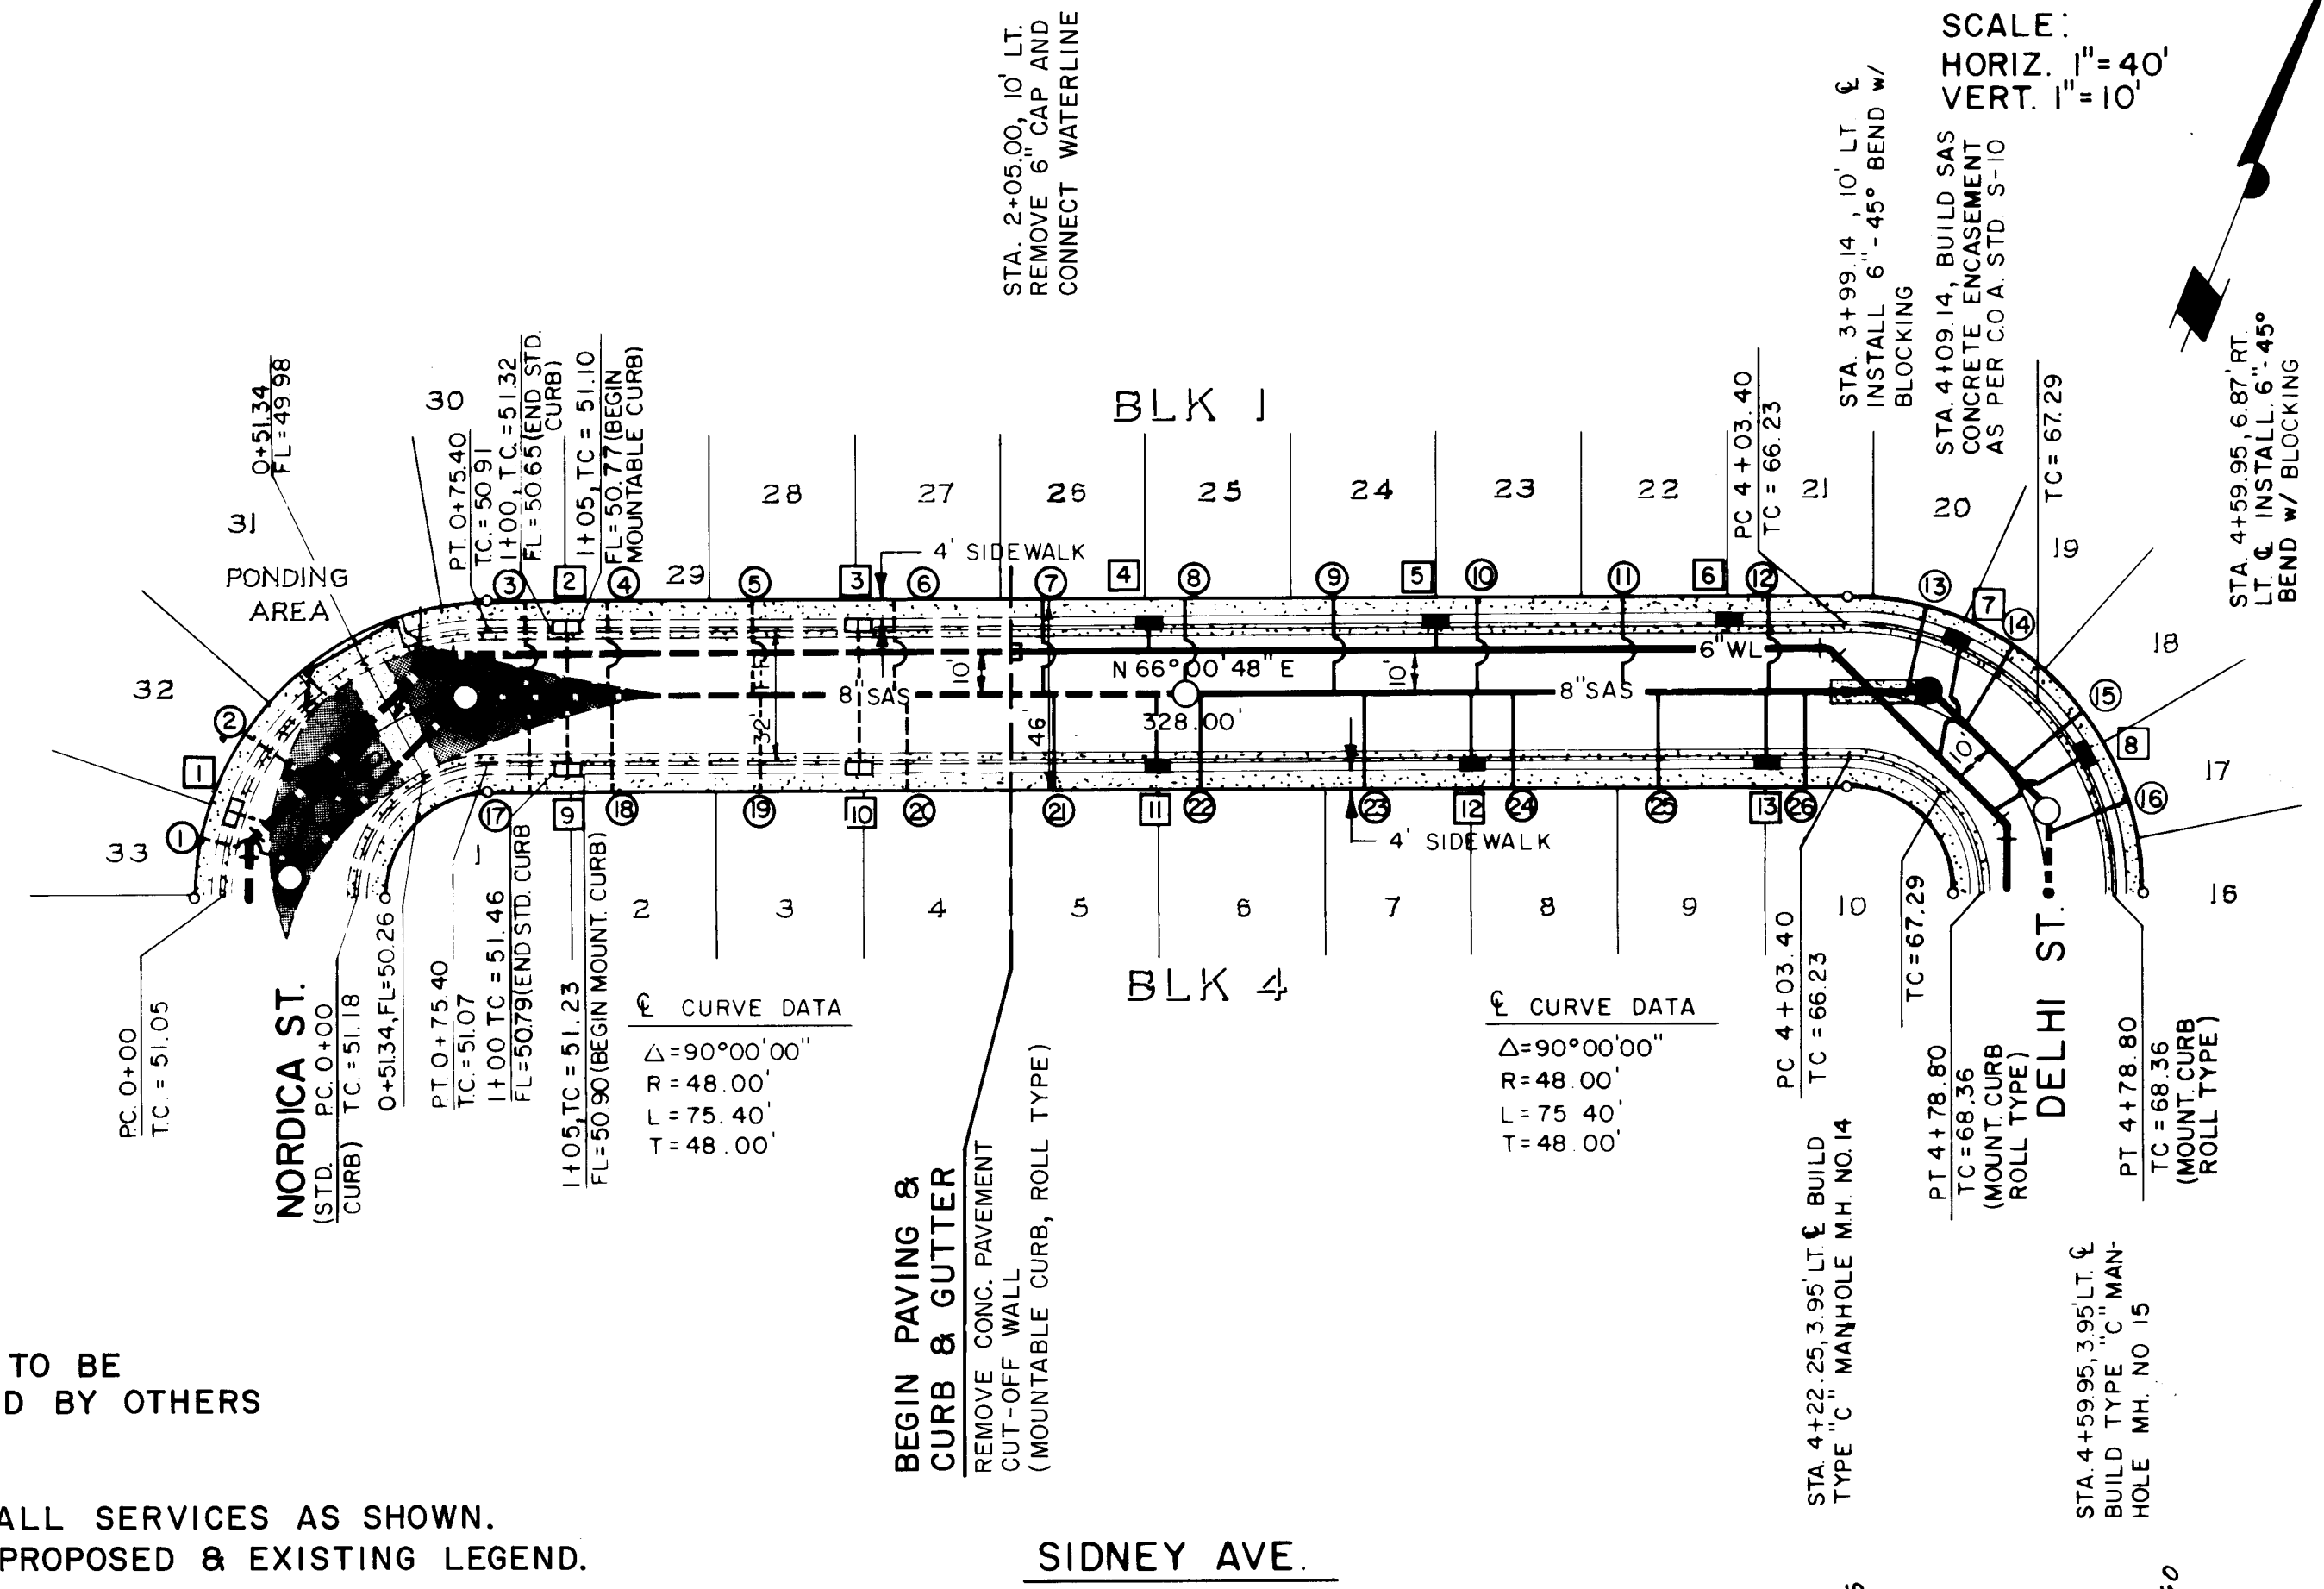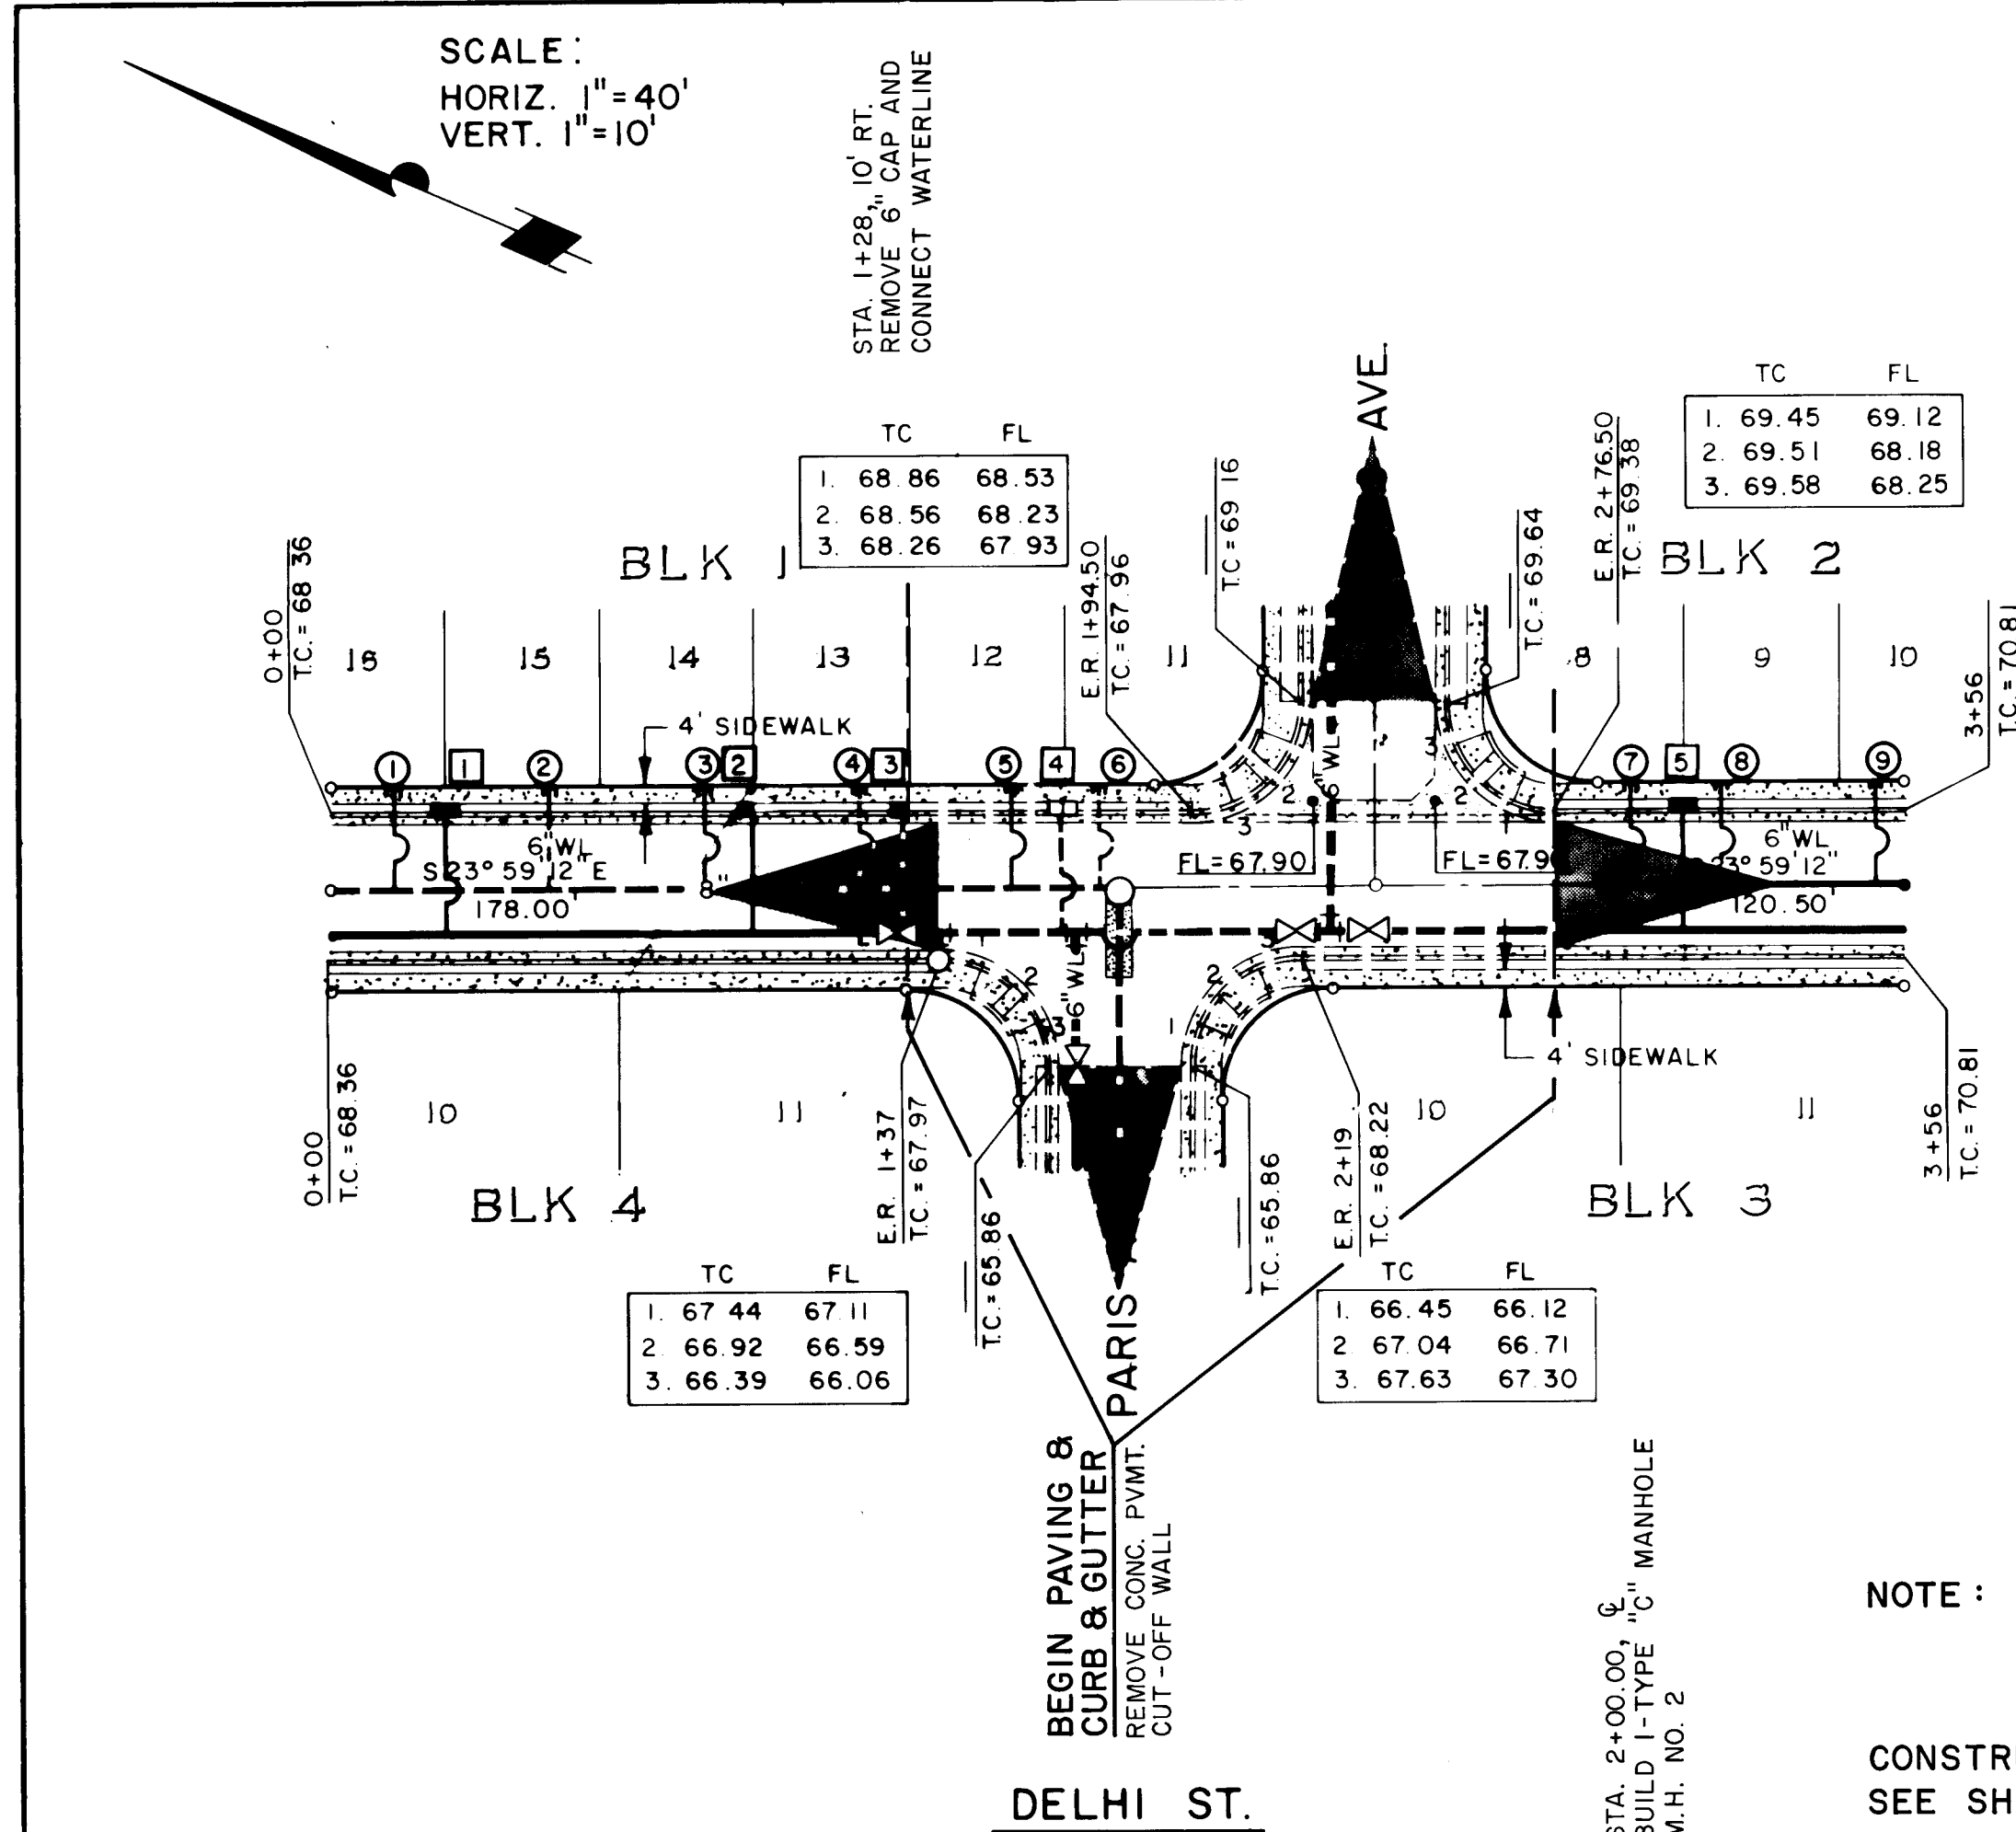

WATER SERVICE TABLE			SEWER SERVICE TABLE			ENGINEER'S SEAL		
SERV. NO.	STATION	LENGTH	SERV. NO.	STATION	LENGTH	NO.	DATE	REVISIONS
1	0+00	2+34	1	0+00	2+34	1	0+00	2+34
2	2+34	3+04	2	2+34	3+04	2	2+34	3+04
3	3+04	3+74	3	3+04	3+74	3	3+04	3+74
4	3+74	4+24	4	3+74	4+24	4	3+74	4+24
5	4+24	4+54	5	4+24	4+54	5	4+24	4+54
6	4+54	4+95	6	4+54	4+95	6	4+54	4+95
7	4+95	5+29	7	4+95	5+29	7	4+95	5+29
8	5+29	5+85	8	5+29	5+85	8	5+29	5+85
9	5+85	6+17	9	5+85	6+17	9	5+85	6+17
10	6+17	6+47	10	6+17	6+47	10	6+17	6+47
11	6+47	6+82	11	6+47	6+82	11	6+47	6+82
12	6+82	7+17	12	6+82	7+17	12	6+82	7+17
13	7+17	7+50	13	7+17	7+50	13	7+17	7+50
14	7+50	7+82	14	7+50	7+82	14	7+50	7+82
15	7+82	8+17	15	7+82	8+17	15	7+82	8+17
16	8+17	8+47	16	8+17	8+47	16	8+17	8+47
17	8+47	8+82	17	8+47	8+82	17	8+47	8+82
18	8+82	9+17	18	8+82	9+17	18	8+82	9+17
19	9+17	9+50	19	9+17	9+50	19	9+17	9+50
20	9+50	9+82	20	9+50	9+82	20	9+50	9+82
21	9+82	10+17	21	9+82	10+17	21	9+82	10+17
22	10+17	10+47	22	10+17	10+47	22	10+17	10+47
23	10+47	10+82	23	10+47	10+82	23	10+47	10+82
24	10+82	11+17	24	10+82	11+17	24	10+82	11+17
25	11+17	11+50	25	11+17	11+50	25	11+17	11+50
26	11+50	11+82	26	11+50	11+82	26	11+50	11+82
27	11+82	12+17	27	11+82	12+17	27	11+82	12+17
28	12+17	12+47	28	12+17	12+47	28	12+17	12+47
29	12+47	12+82	29	12+47	12+82	29	12+47	12+82
30	12+82	13+17	30	12+82	13+17	30	12+82	13+17
31	13+17	13+50	31	13+17	13+50	31	13+17	13+50
32	13+50	13+82	32	13+50	13+82	32	13+50	13+82
33	13+82	14+17	33	13+82	14+17	33	13+82	14+17
34	14+17	14+50	34	14+17	14+50	34	14+17	14+50
35	14+50	14+82	35	14+50	14+82	35	14+50	14+82
36	14+82	15+17	36	14+82	15+17	36	14+82	15+17
37	15+17	15+50	37	15+17	15+50	37	15+17	15+50
38	15+50	15+82	38	15+50	15+82	38	15+50	15+82
39	15+82	16+17	39	15+82	16+17	39	15+82	16+17
40	16+17	16+50	40	16+17	16+50	40	16+17	16+50
41	16+50	16+82	41	16+50	16+82	41	16+50	16+82
42	16+82	17+17	42	16+82	17+17	42	16+82	17+17
43	17+17	17+50	43	17+17	17+50	43	17+17	17+50
44	17+50	17+82	44	17+50	17+82	44	17+50	17+82
45	17+82	18+17	45	17+82	18+17	45	17+82	18+17
46	18+17	18+50	46	18+17	18+50	46	18+17	18+50
47	18+50	18+82	47	18+50	18+82	47	18+50	18+82
48	18+82	19+17	48	18+82	19+17	48	18+82	19+17
49	19+17	19+50	49	19+17	19+50	49	19+17	19+50
50	19+50	19+82	50	19+50	19+82	50	19+50	19+82
51	19+82	20+17	51	19+82	20+17	51	19+82	20+17
52	20+17	20+50	52	20+17	20+50	52	20+17	20+50
53	20+50	20+82	53	20+50	20+82	53	20+50	20+82
54	20+82	21+17	54	20+82	21+17	54	20+82	21+17
55	21+17	21+50	55	21+17	21+50	55	21+17	21+50
56	21+50	21+82	56	21+50	21+82	56	21+50	21+82
57	21+82	22+17	57	21+82	22+17	57	21+82	22+17
58	22+17	22+50	58	22+17	22+50	58	22+17	22+50
59	22+50	22+82	59	22+50	22+82	59	22+50	22+82
60	22+82	23+17	60	22+82	23+17	60	22+82	23+17
61	23+17	23+50	61	23+17	23+50	61	23+17	23+50
62	23+50	23+82	62	23+50	23+82	62	23+50	23+82
63	23+82	24+17	63	23+82	24+17	63	23+82	24+17
64	24+17	24+50	64	24+17	24+50	64	24+17	24+50
65	24+50	24+82	65	24+50	24+82	65	24+50	24+82
66	24+82	25+17	66	24+82	25+17	66	24+82	25+17
67	25+17	25+50	67	25+17	25+50	67	25+17	25+50
68	25+50	25+82	68	25+50	25+82	68	25+50	25+82
69	25+82	26+17	69	25+82	26+17	69	25+82	26+17
70	26+17	26+50	70	26+17	26+50	70	26+17	26+50
71	26+50	26+82	71	26+50	26+82	71	26+50	26+82
72	26+82	27+17	72	26+82	27+17	72	26+82	27+17
73	27+17	27+50	73	27+17	27+50	73	27+17	27+50
74	27+50	27+82	74	27+50	27+82	74	27+50	27+82
75	27+82	28+17	75	27+82	28+17	75	27+82	28+17
76	28+17	28+50	76	28+17	28+50	76	28+17	28+50
77	28+50	28+82	77	28+50	28+82	77	28+50	28+82
78	28+82	29+17	78	28+82	29+17	78	28+82	29+17
79	29+17	29+50	79	29+17	29+50	79	29+17	29+50
80	29+50	29+82	80	29+50	29+82	80	29+50	29+82
81	29+82	30+17	81	29+82	30+17	81	29+82	30+17
82	30+17	30+50	82	30+17	30+50	82	30+17	30+50
83	30+50	30+82	83	30+50	30+82	83	30+50	30+82
84	30+82	31+17	84	30+82	31+17	84	30+82	31+17
85	31+17	31+50	85	31+17	31+50	85	31+17	31+50
86	31+50	31+82	86	31+50	31+82	86	31+50	31+82
87	31+82	32+17	87	31+82	32+17	87	31+82	32+17
88	32+17	32+50	88	32+17	32+50	88	32+17	32+50
89	32+50	32+82	89	32+50	32+82	89	32+50	32+82
90	32+82	33+17	90	32+82	33+17	90	32+82	33+17
91	33+17	33+50	91	33+17	33+50	91	33+17	33+50
92	33+50	33+82	92	33+50	33+82	92	33+50	33+82
93	33+82	34+17	93	33+82	34+17	93	33+82	34+17
94	34+17	34+50	94	34+17	34+50	94	34+17	34+50
95	34+50	34+82	95	34+50	34+82	95	34+50	34+82
96	34+82	35+17	96	34+82	35+17	96	34+82	35+17
97	35+17	35+50	97	35+17	35+50	97	35+17	35+50
98	35+50	35+82	98	35+50	35+82	98	35+50	35+82
99	35+82	36+17	99	35+82	36+17	99	35+82	36+17
100	36+17	36+50	100	36+17	36+50	100	36+17	36+50

26 22090785

 

CITY OF ALBUQUERQUE
MUNICIPAL DEVELOPMENT DEPARTMENT
ENGINEERING DIVISION

TITLE: ACADEMY SQUARE SUBDIVISION UNIT I
DELHI ST. & SIDNEY AVE.

APPROVALS: ENGINEER DATE APPROVALS ENGINEER DATE
City Engineer: [Signature] 9/1/04 Liquid Waste R. Paine 8/8/04
A.C.E. Design: [Signature] 8/1/04 Traffic [Signature] 8/8/04
Hydrology: [Signature] 8/1/04 Water [Signature] 8/8/04

DRAWING NO. 2209 MAP NO. F-21 SHEET 7 OF 8

D.G.A. JOB NO. 616.32

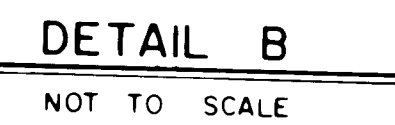

Assume critical depth will occur on the spillway. Then

$$\text{Froude}^2 = 1 = \frac{Q^2}{32.2 L^3 D^3} \text{ or } L = (38^2 / (32.2 \times 0.4^3))^{\frac{1}{3}} = 26.5 \text{ ft.}$$

**APPROVED FOR
CONSTRUCTION**


CITY ENGINEER

D.6 A JOB NO. 616.32

GENERAL NOTES

1. All existing utilities shown were taken from Record Drawings and are located as accurately as possible from information available. It will be the Contractor's responsibility to verify exact locations of these utilities before construction begins.
2. All tees, wyes, bends and other connections require concrete thrust blocking as detailed and defined in the City of Albuquerque's Standard Drawings W-22.
3. Waterlines may be deflected at the joint so as to conform to the location shown on the plans. A maximum of 2" deflection per joint will be allowed.
4. All sanitary sewer manholes shall be type "C" 4' Dia., City of Albuquerque Standard Drawing S-1-3, unless otherwise noted.
5. Sewer service lines shall be installed per City of Albuquerque Standard Drawings S-8-3.
6. 3' minimum cover on all waterlines.
7. Water valve boxes to be Type "A" per City of Albuquerque Standard Drawings W-2-3.
8. Fire hydrants are to be installed in accordance with City of Albuquerque Standard Drawing W-20-1.
9. Connections to existing waterlines shall be in accordance with City of Albuquerque Standard Drawing W-1-2.
10. The Contractor will coordinate his construction activities with other Contractors.
11. The specifications used for this project will be City of Albuquerque Contract Documents, Public Works Contract No. 84-1.
12. All reference to City Standard Details will be per City of Albuquerque Contract Documents, Public Works Contract No. 84-1.
13. The Contractor shall notify all utility companies when working near their systems and shall have the utility companies locate utilities prior to excavation, call 765-1234 regarding location of utility lines. Utility companies shall be given 48 hours advance notice for line location.
14. Policy On The Proximity Of Water & Sewer Lines: "Whenever possible, it is desirable to lay parallel water and sewer lines at least 10 feet apart horizontally, and the waterline should be at a higher elevation than the sewer. If this is not possible, separate trenches will be required in all cases (this shall be effective even though one line has been installed prior to the other), and the waterline shall be at least 2 feet above the sewer. When water and sewer lines cross each other, the waterline shall be at least 18 inches above the sewer; otherwise the sewer shall be of Ductile iron pipe. A preferred alternative is Encasement in concrete as shown in the City's Standard Details for 10ft. on each side of the waterline. If Ductile iron pipe is used, it must be run from manhole to manhole.
15. All dimensions from face of curb to face of curb unless otherwise shown.
16. All radii of curb return are to face of curb. Radii to be 25' unless otherwise noted.
17. All finished grades, profiles and spot elevations shown are top of curb, unless otherwise noted.
18. When abutting new pavement to existing pavement, cut back old pavement to a neat straight line as required to remove any broken or cracked pavement and match new to existing. No separate payment will be made for abutting existing pavement, but shall be considered incidental to the project. Cutting of pavement shall be in conformance with the specifications.
19. Subgrade preparation under sidewalks shall be considered incidental to the construction of such and shall be included in the bid price for such items.
20. For construction of wheelchair ramps see City Standard Drawings P-16-1 and P-17.
21. Construct concrete valley gutter per City Standard Drawing P-9-2.
22. Sidewalk to be built per City of Albuquerque Standard Drawing P-13-2.
23. The Contractor must submit a Traffic Control Plan and receive a barricading permit prior to construction in Juan Tabo R.O.W.
24. All water system gate valves shall be of the resilient seat type.
25. The following list of pipe materials are acceptable for water and sewer main construction under Public Works Contract 84-2.
- Water Mains: Polyvinyl Chloride Pipe
Asbestos Concrete Pipe
Ductile Iron Pipe
- Sanitary Sewer: Vitrified Clay Pipe
Polyvinyl Chloride Pipe
- All Classes of the above pipe types shall conform to City of Albuquerque Specifications.

LEGEND

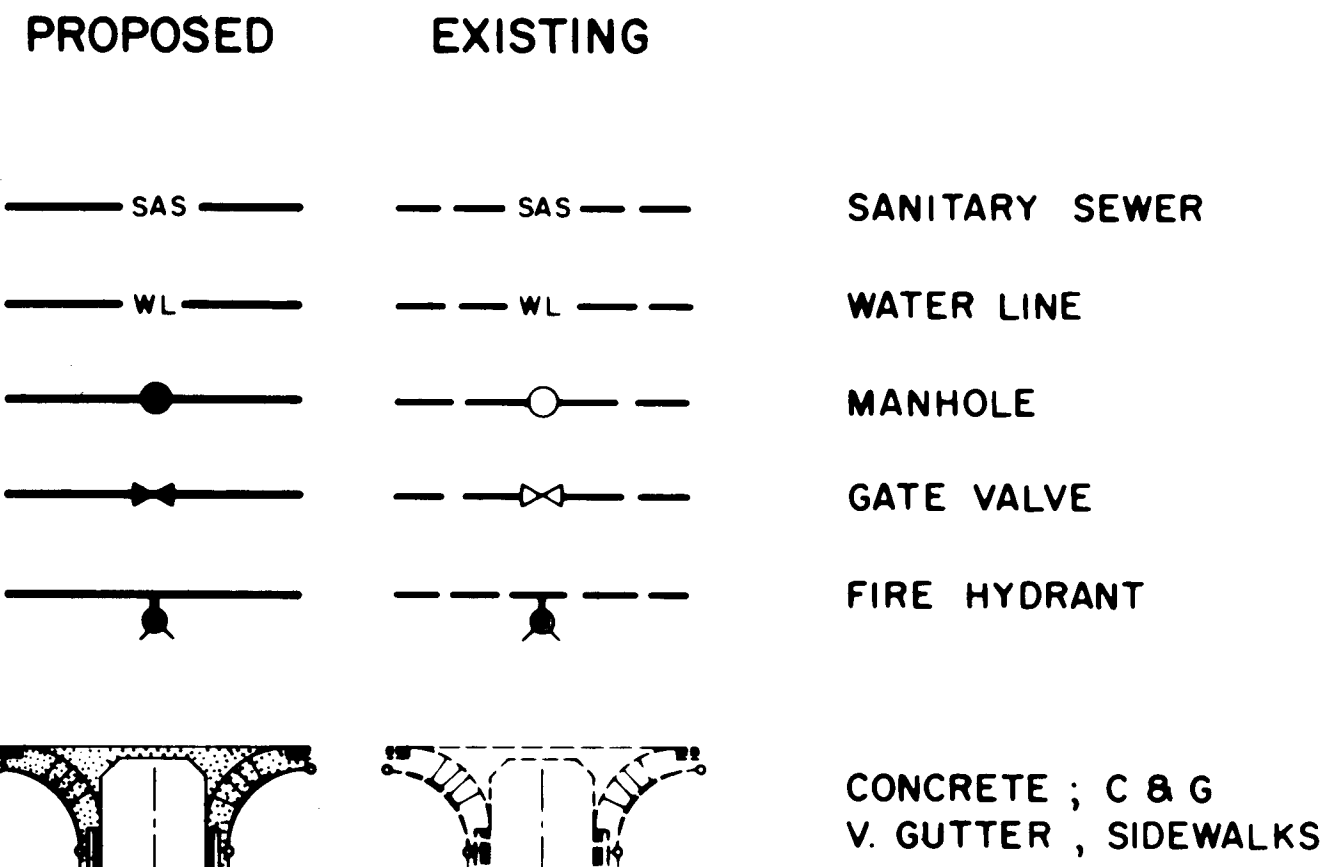


1 2 3 4 5 6 7 8 9 10 11 12
26 2209 0285



APPROVED FOR
CONSTRUCTION

CITY ENGINEER DATE

CITY OF ALBUQUERQUE MUNICIPAL DEVELOPMENT DEPARTMENT ENGINEERING DIVISION					
TITLE: ACADEMY SQUARE SUBDIVISION UNIT I GENERAL NOTES & LEGEND					
APPROVALS	ENGINEER	DATE	APPROVALS	ENGINEER	DATE
City Engineer	<i>C. J. Thompson</i>	8/10/84	Liquid Waste	<i>R. T. Davis</i>	8/10/84
A.C.E. Design	<i>A.C.E. Design</i>	8/25/84	Traffic	<i>D. J. W. Thomas</i>	8/9/84
Hydrology	<i>B. J. Boudreau</i>	8/6/84	Water	<i>R. T. Davis</i>	8/6/84
DRAWING NO. 2209			SHEET 2 OF 8		

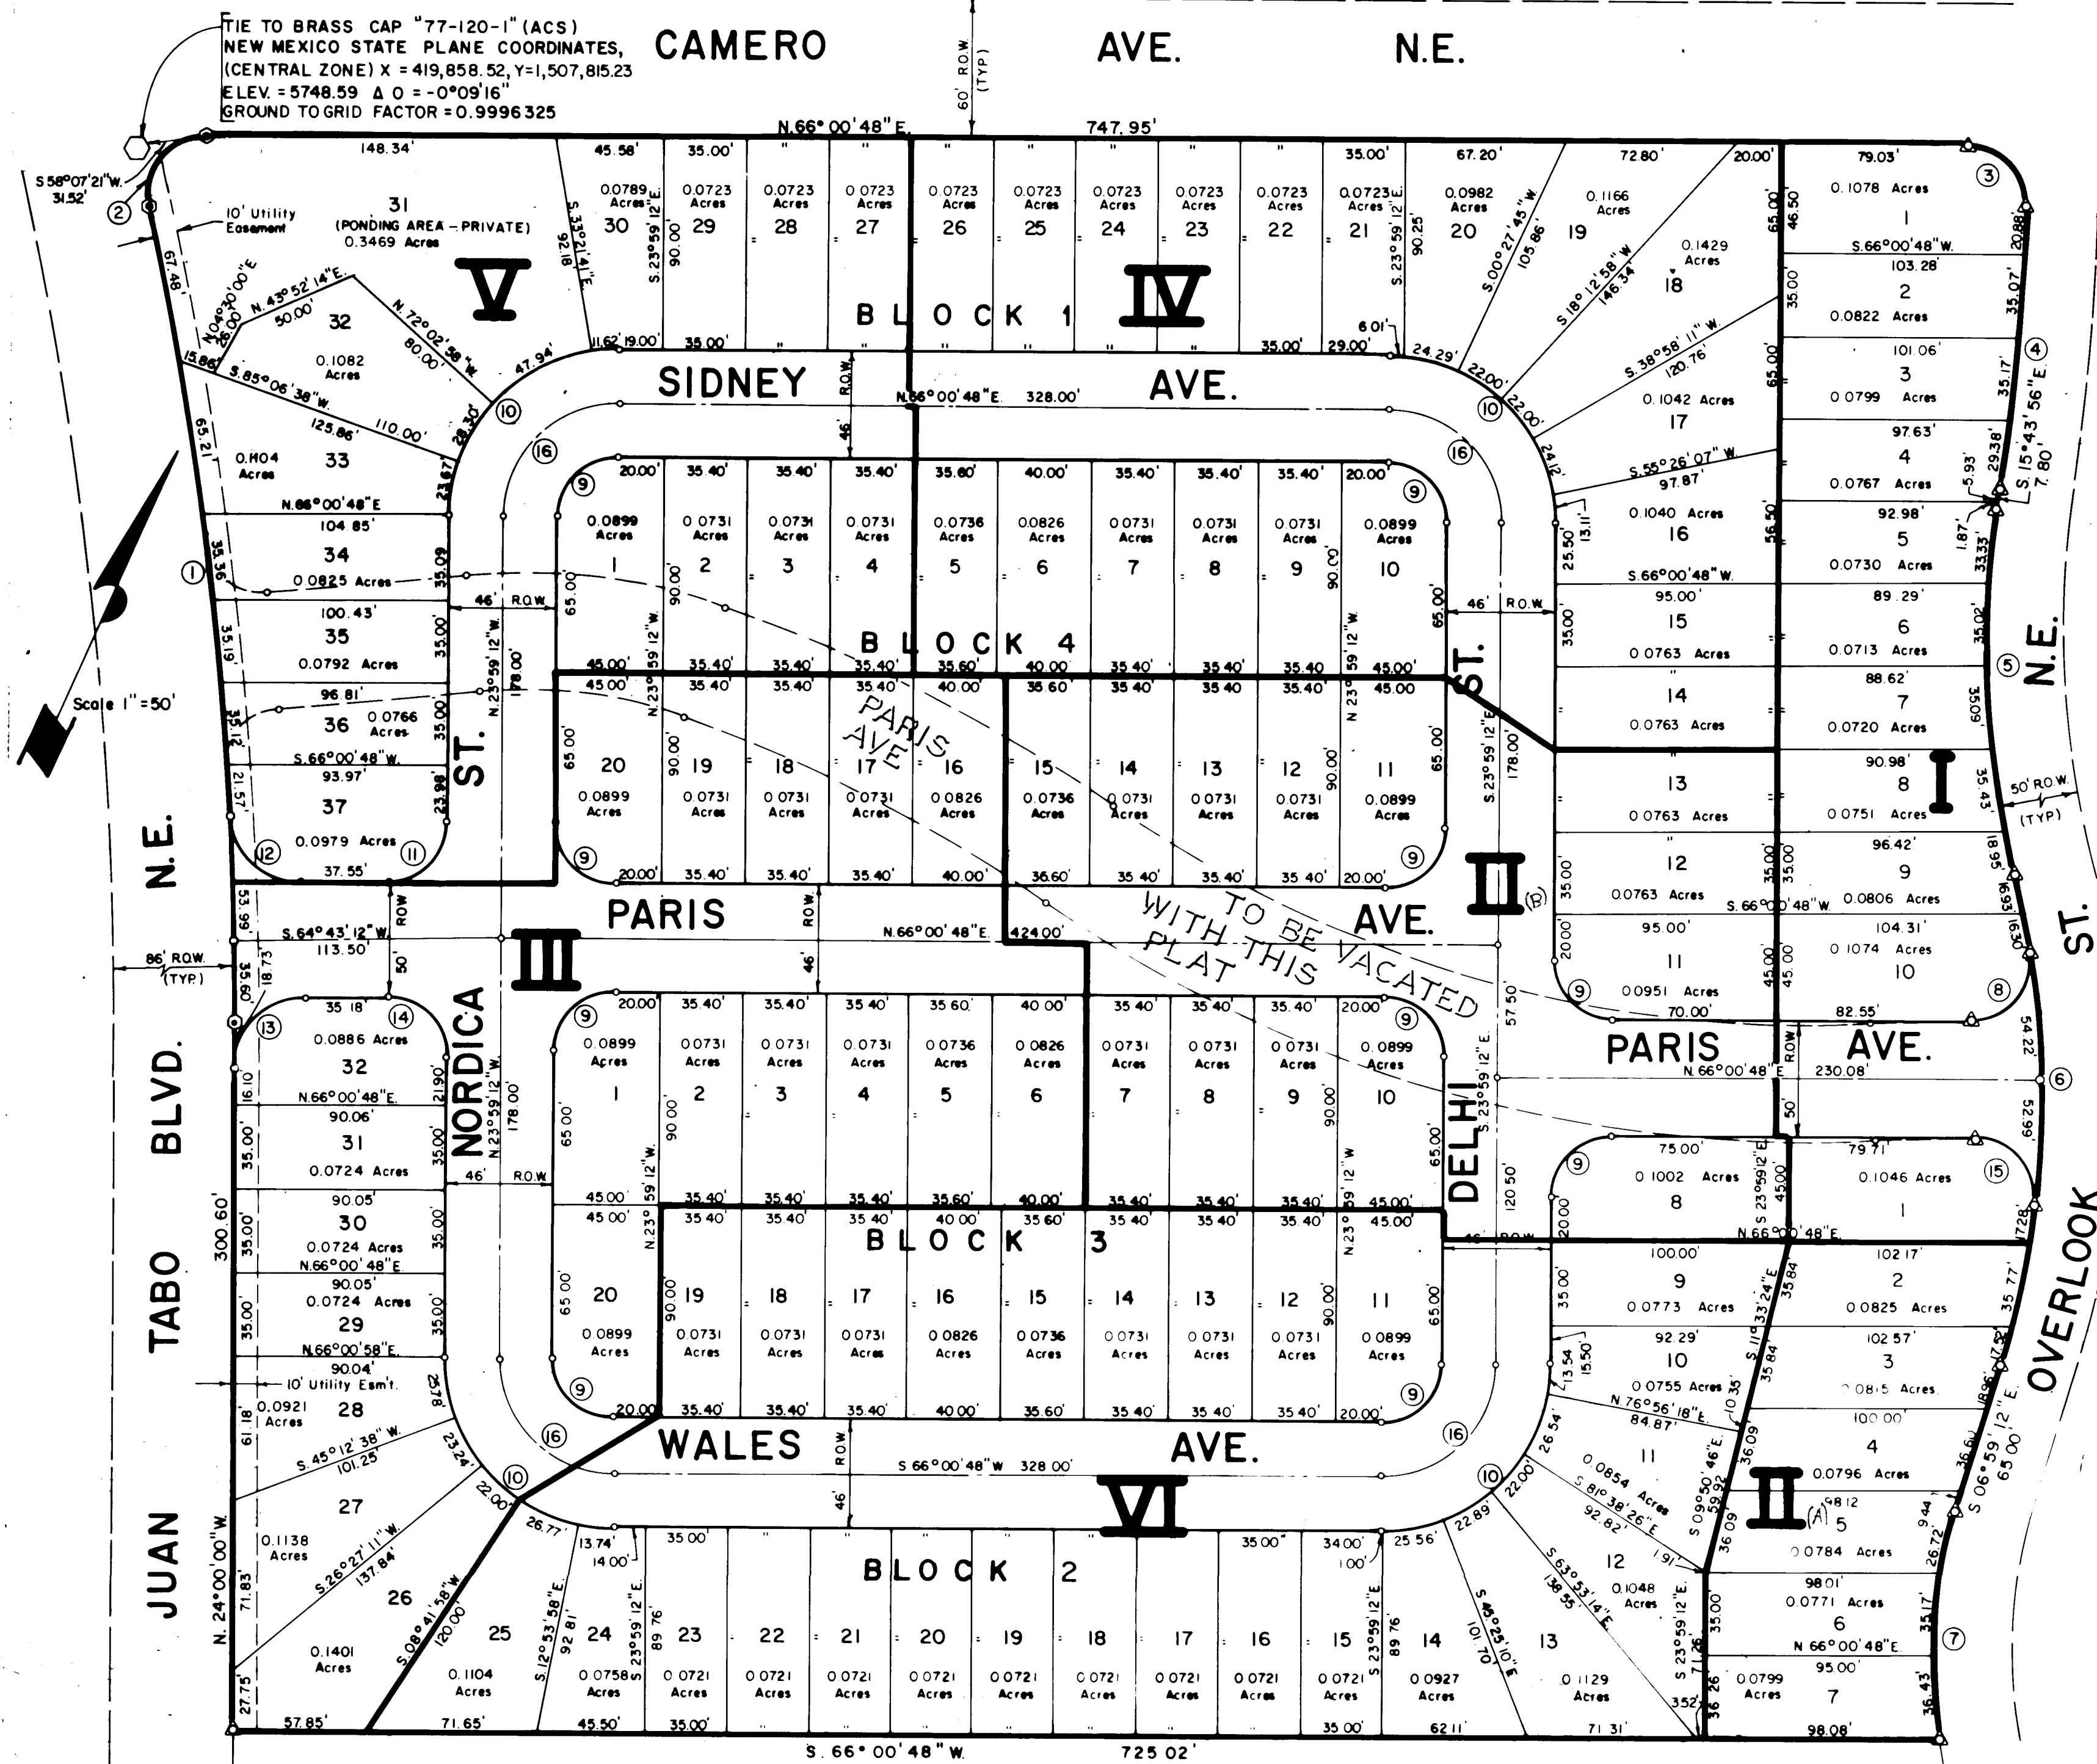

REPLAT OF TRACTS B & C ACADEMY SQUARE UNIT ONE

BERNALILLO COUNTY
ALBUQUERQUE, NEW MEXICO
SEPTEMBER 1983

CURVE DATA

MARK	DELTA	RADIUS	LENGTH	TANGENT
①	12° 33' 56"	1593.71'	349.52'	175.46'
②	102° 34' 44"	25.00'	44.76'	31.19'
③	91° 26' 52"	25.00'	39.90'	25.64'
④	06° 48' 24"	1014.38'	120.51'	60.32'
⑤	22° 15' 17"	406.32'	157.82'	79.92'
⑥	31° 00' 01"	390.00'	211.01'	108.16'
⑦	26° 49' 30"	210.00'	98.32'	50.08'
⑧	99° 07' 03"	25.00'	43.25'	29.33'
⑨	90° 00' 00"	25.00'	39.27'	25.00'
⑩	90° 00' 00"	71.00'	111.53'	71.00'
⑪	88° 42' 25"	25.00'	38.71'	24.44'
⑫	88° 03' 32"	30.00'	46.11'	29.00'
⑬	88° 43' 12"	30.00'	46.45'	29.34'
⑭	91° 17' 35"	25.00'	39.83'	25.57'
⑮	96° 37' 50"	25.00'	42.16'	28.08'
⑯	90° 00' 00"	18.00'	75.40'	48.00'

LEGEND

- ⊙ Found No. 4 Rebar
- △ Set No. 5 Rebar w/ Cap LS 4100

LEGEND

- V** LOT DEVELOPMENT PHASES ARE INDICATED BY ROMAN NUMERALS
- BOLD LINE INDICATES PHASE BOUNDARY

PHASED CONSTRUCTION SEQUENCE ACADEMY SQUARE, UNIT ONE

THE CITY OF ALBUQUERQUE DEVELOPMENT REVIEW BOARD HAS APPROVED THE PHASING OF THE SUBDIVISION AS ILLUSTRATED. PHASE I HAS BEEN PLATTED AND RECORDED AND CONSTRUCTION IS IN PROGRESS. BEFORE THE DEVELOPER CAN PROCEED WITH SUBSEQUENT PHASES, THE COMPLETE SET OF CONSTRUCTION DOCUMENTS MUST BE APPROVED, THEN THE DEVELOPER MAY SUBMIT FINAL PLATS FOR EACH PHASE.

THE GEOMETRY GIVEN ON THE DRAWING ABOVE, REPRESENTS THE GEOMETRY THAT WILL BE UTILIZED AS IF THE SUBDIVISION WAS BEING PLATTED IN ITS ENTIRETY.

AS BUILT INFORMATION				BENCH MARKS		SURVEY INFORMATION				REFERENCES				FIELD NOTES				MICRO-FILM INFORMATION							
CONTRACTOR						MAP NO.				W.O. NO.				NO.				BY				DATE			
WORK STARTED BY				DATE		EST. NO.																			
FIELD ACCEPTANCE BY				DATE																					
FIELD ACCEPTANCE BY				DATE																					
DRAWINGS				DATE																					
CONNECTED BY				DATE																					
RECORDED BY				DATE																					
NO																									

26 2209 385



APPROVED FOR
CONSTRUCTION

CITY ENGINEER DATE

CITY OF ALBUQUERQUE PUBLIC WORKS DEPARTMENT ENGINEERING DIVISION			
TITLE: ACADEMY SQUARE SUBDIVISION UNIT I PLAT			
APPROVALS	DATE	APPROVALS	ENGINEER
City Engineer		Liquid Waste	R. J. Jarama
A.C.E. - Design	8/25/83	NA DWH	8/25/83
Hydrology	8/25/83	Water	8/25/83
DRAWING NO.	2209	SHEET	3 OF 8