

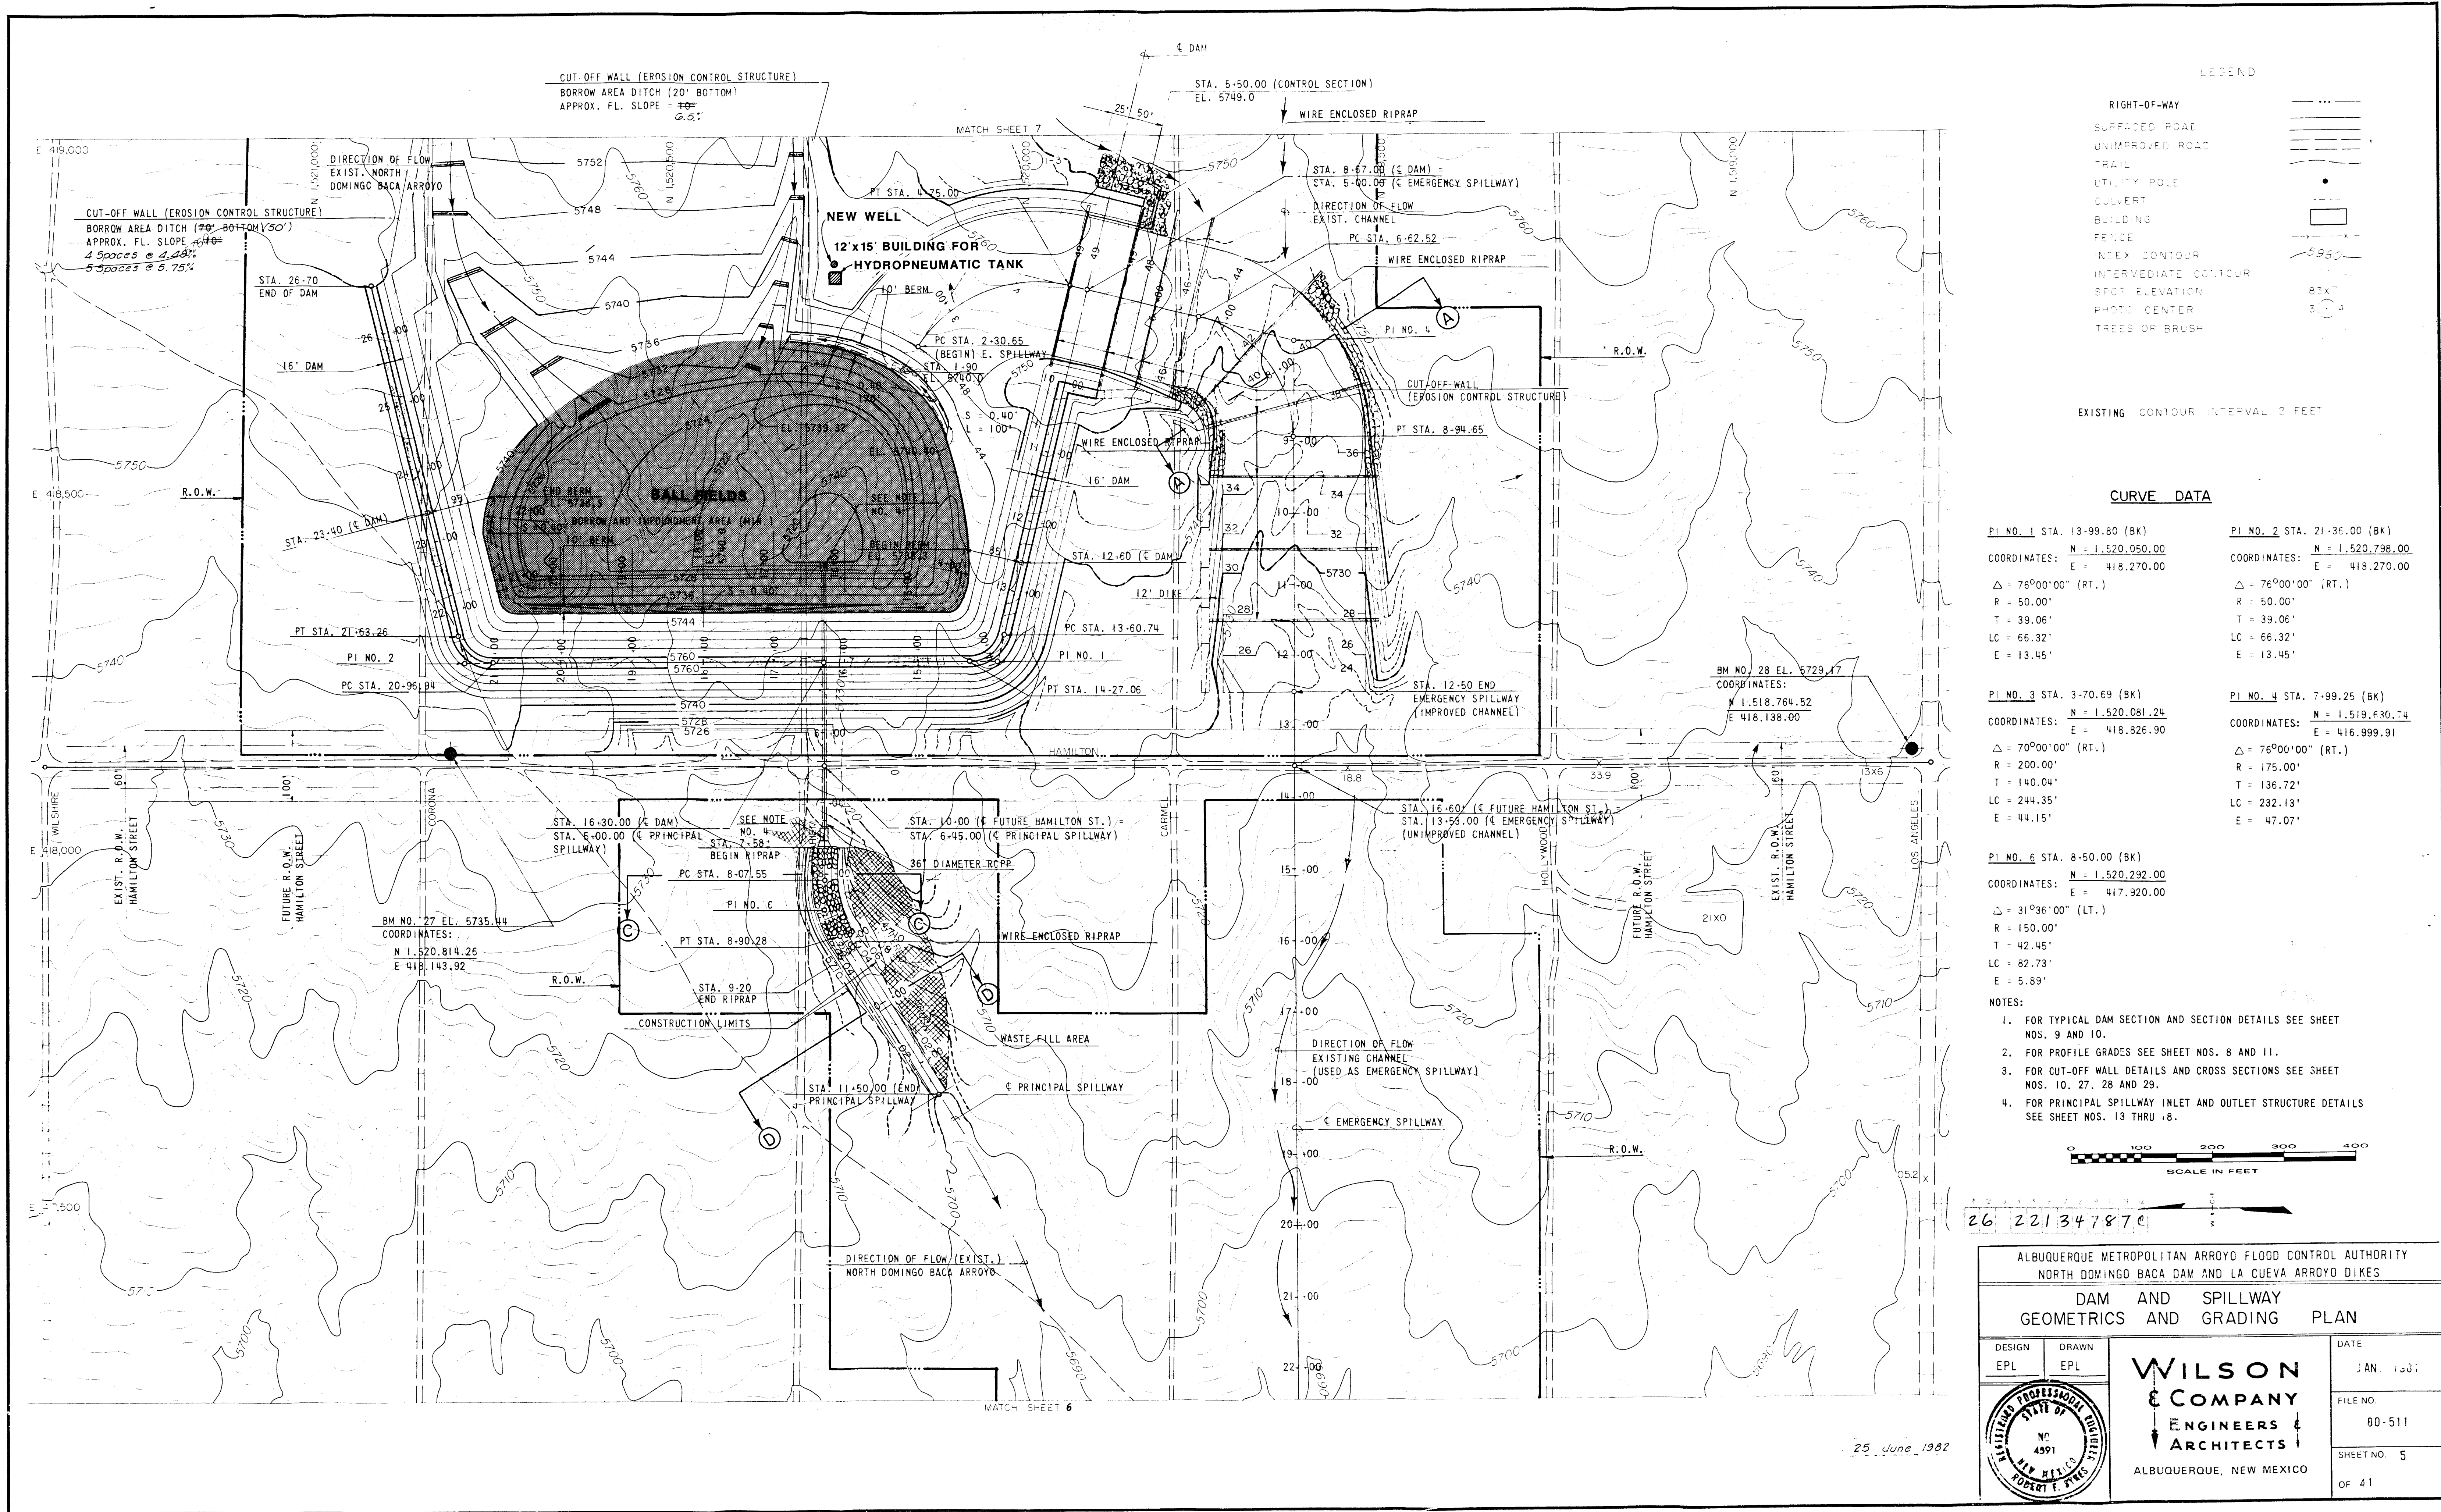


FIGURE NO. 3

	AIR VALVE
	WATER VALVE
	BACKFLOW PREVENTER
	CHECK VALVE

... (at P)
... 48 W
...
...

Sta 0+73.78
1 48" Butterfly Valve
1 54" x 48" Reducer
1 54" x 54" x 54" Tee
2 54" Butterfly Valves
3 1/2" B Valve Boxes
1 54" Blind Flange
(3/4" Plywood Placed On
54" Butterfly Valve)

1. 2. 3. 840. 84

100

100

Sta 5+17.25
1 36" x 36" x 18" Tee
1 36" Butterfly Valve
1 18" Butterfly Valve
2 Type B Valve Boxes

Sta 0+72.58
12.4 x 90° R.C.C.
1.54 x 45' Bend

Sta 0+0.00
1 36" x 36" x 36" Tee
2 36" x 24" Reducer
1 24" Blind Flange

4" PVC Drain Line •

6.5 M.G. (CONCRETE) RESERVOIR

Sta. 4+64.94

1' 54" (branch) x 36" (run) x 36" (run)

x 22 1/2" Bend (special fitting)

1' 36" Plug

See detail sheet 1C

Tank Floor El. 5687.0

Overflow El. 5710.0

NOTE: Pay Limits for Conc.Res. shall be 5'-0" outside of Ringwall

LAYOUT PLAN

RECORD DRAWING
FFB 8 1963

AVENUE NE^W York, New York, is a firm licensed based
in New York, New York, to perform the design and construction attempt
of the proposed project. The project is a proposed construction of
a new building, which is currently in the planning stage.

GRAPHIC SCALE

[illegible]

| | | | | | | | | | | | |
|---|---|--|---|---|---|---|---|---|---|---|---|
| 2 | 6 | | 2 | 2 | 1 | 3 | 4 | 7 | 8 | 7 | A |
|---|---|--|---|---|---|---|---|---|---|---|---|

ALBUQUERQUE, NEW MEXICO

WALKER RESERVOIR

LOT NO 2

CONCRETE RESERVOIR
SITE PLAN


GORDON HERKENHOFF & ASSOCIATES, INC.
ENGINEERS ARCHITECTS PLANNERS
ALBUQUERQUE, N.M. PHOENIX, ARIZONA TAMPA, FLORIDA

ALBUQUERQUE, N. M. FARMINGTON, N. M. ALBUQUERQUE, N. M.


~~SHEET 4 OF 22~~
FIGURE NO. 1

LEGEND


- ASPHALT ROADWAY
- CONCRETE ROADWAY
- WATER LINES
- BUTTERFLY VALVE
- CHECK VALVE

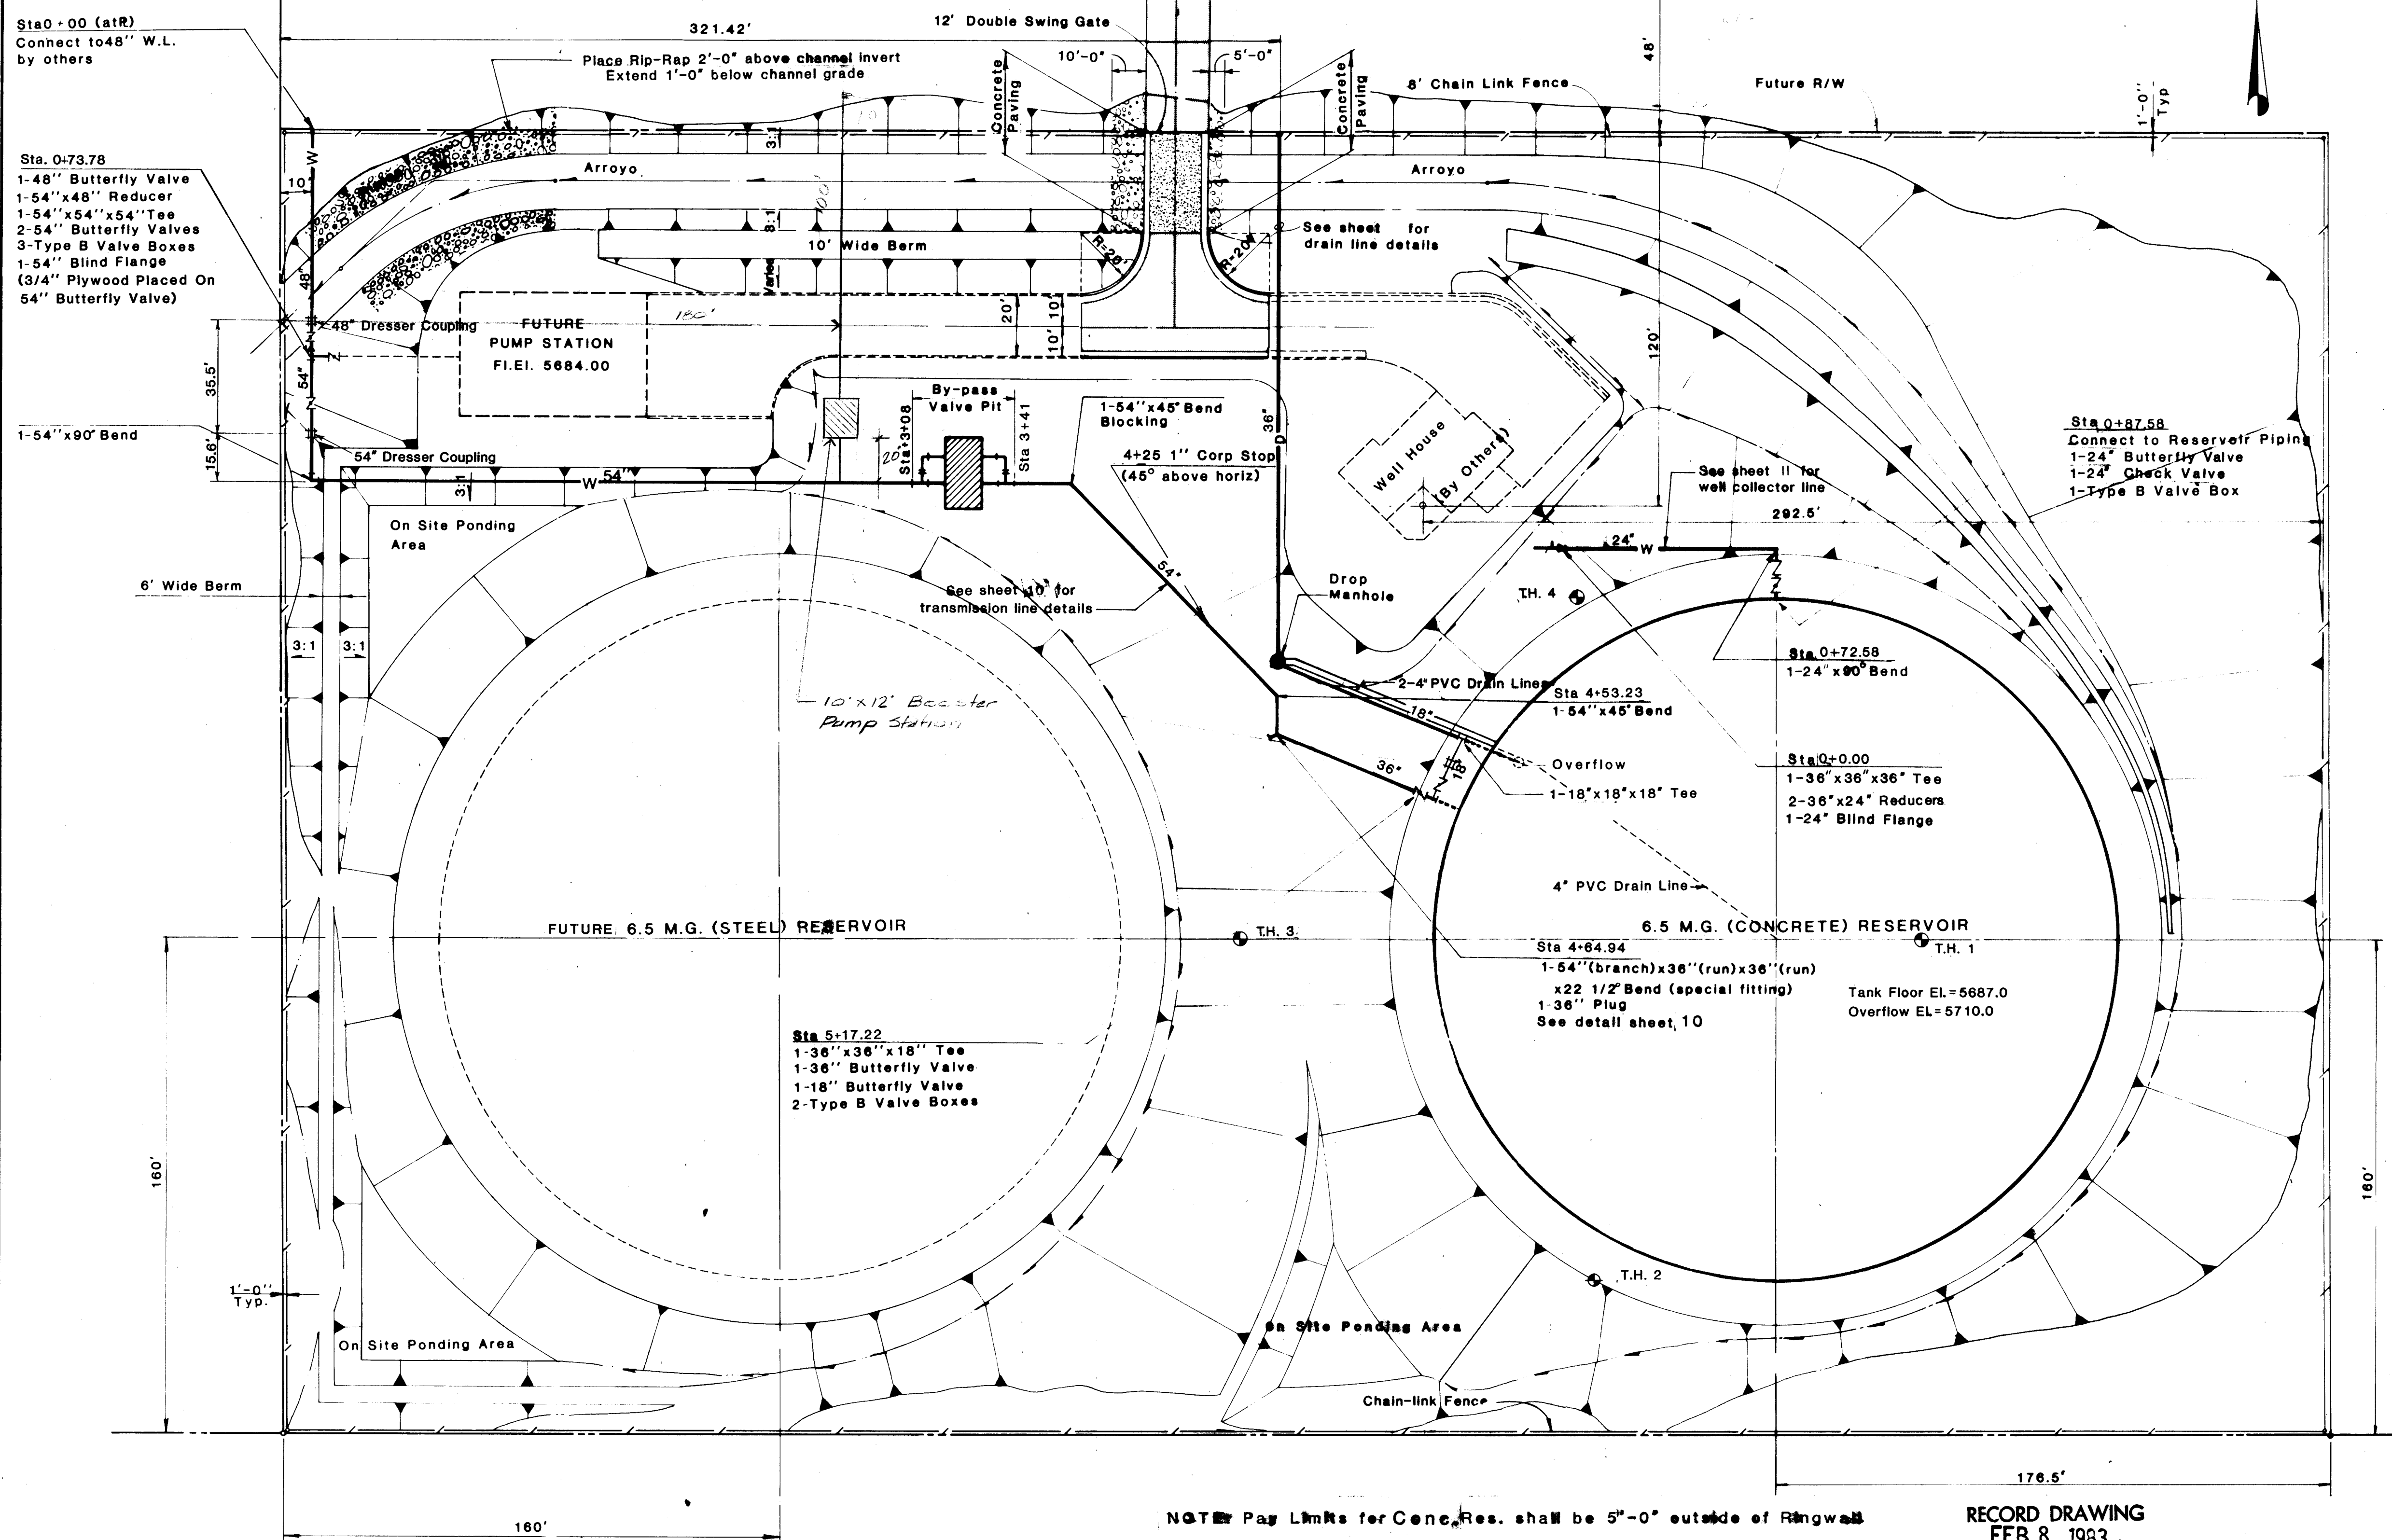


TEST HOLE # 1

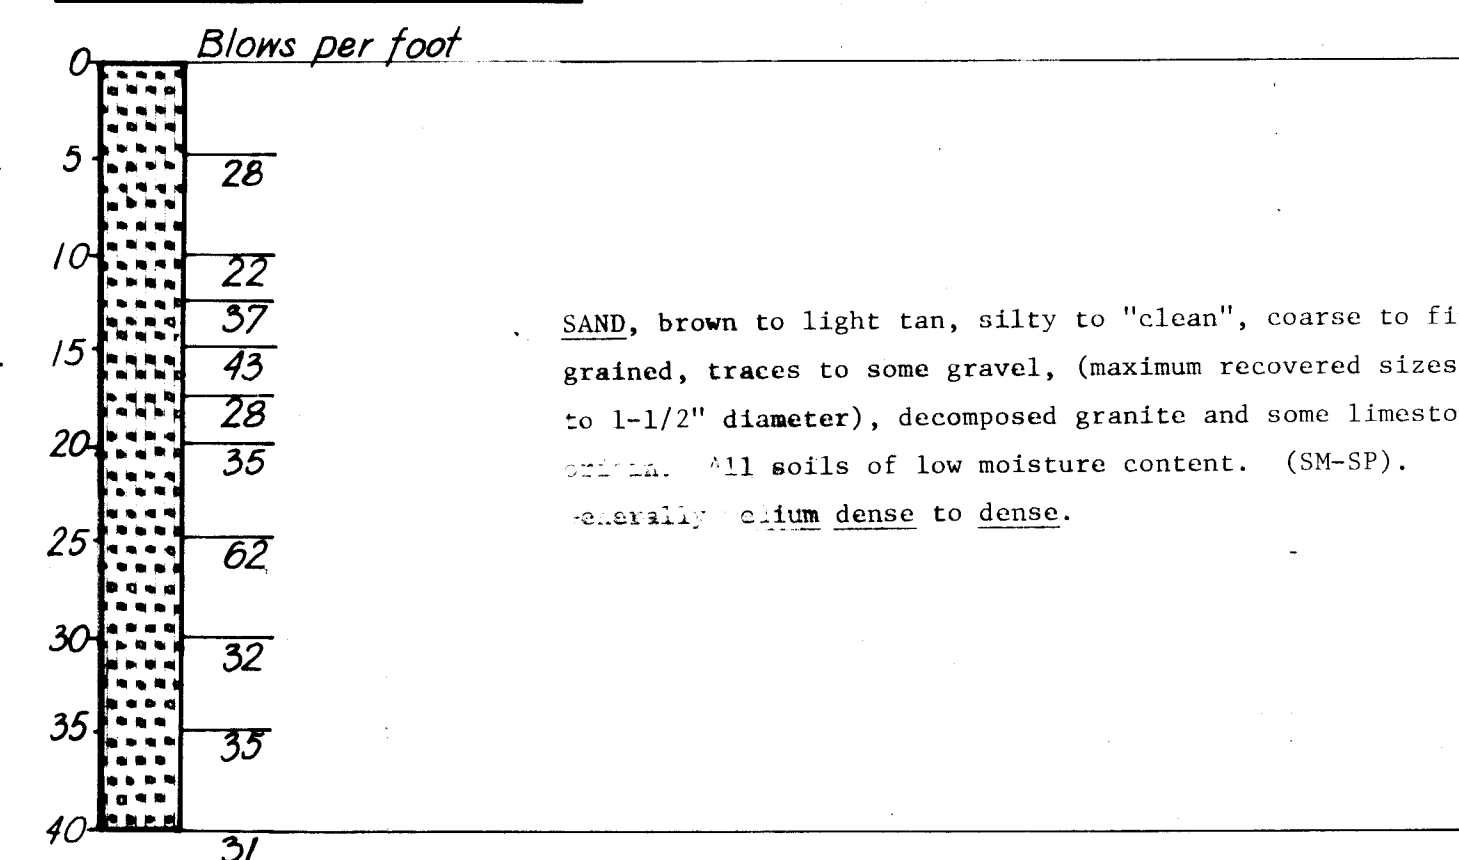


TEST HOLE # 2

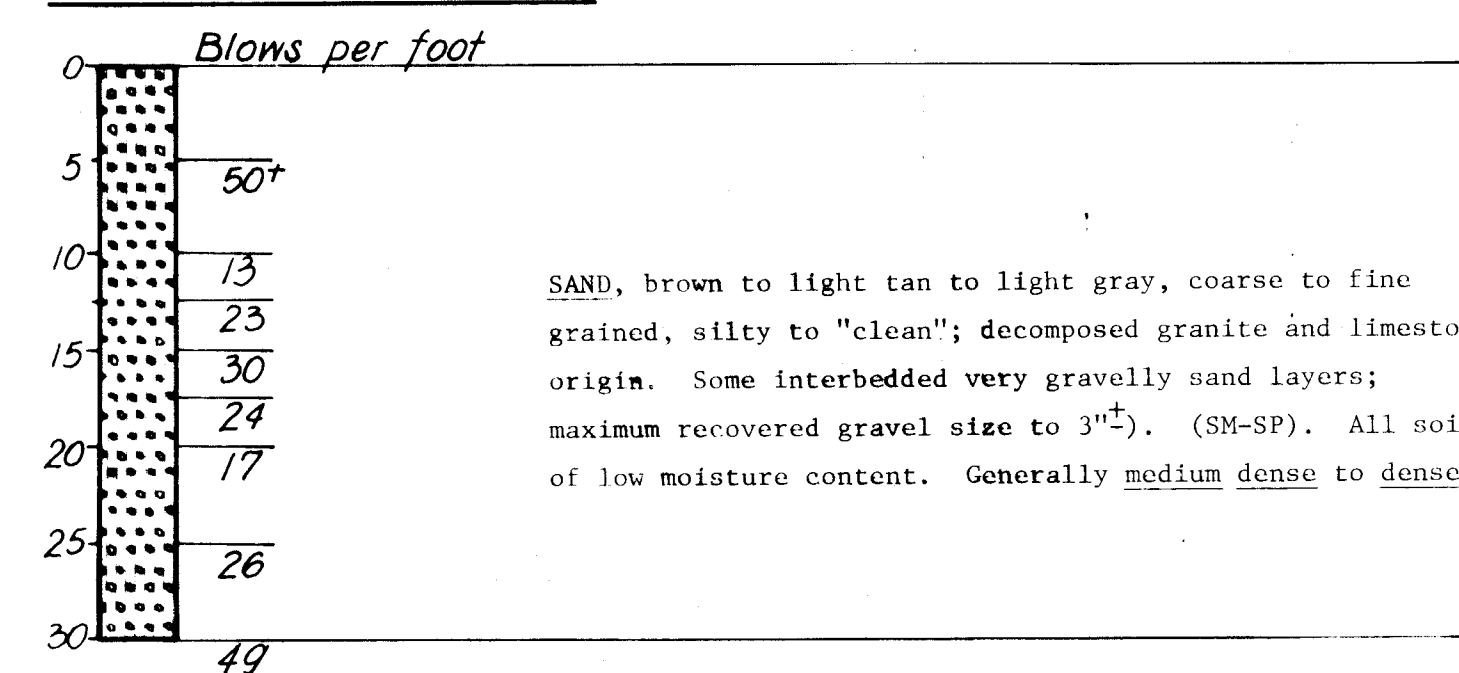

TEST HOLE # 3

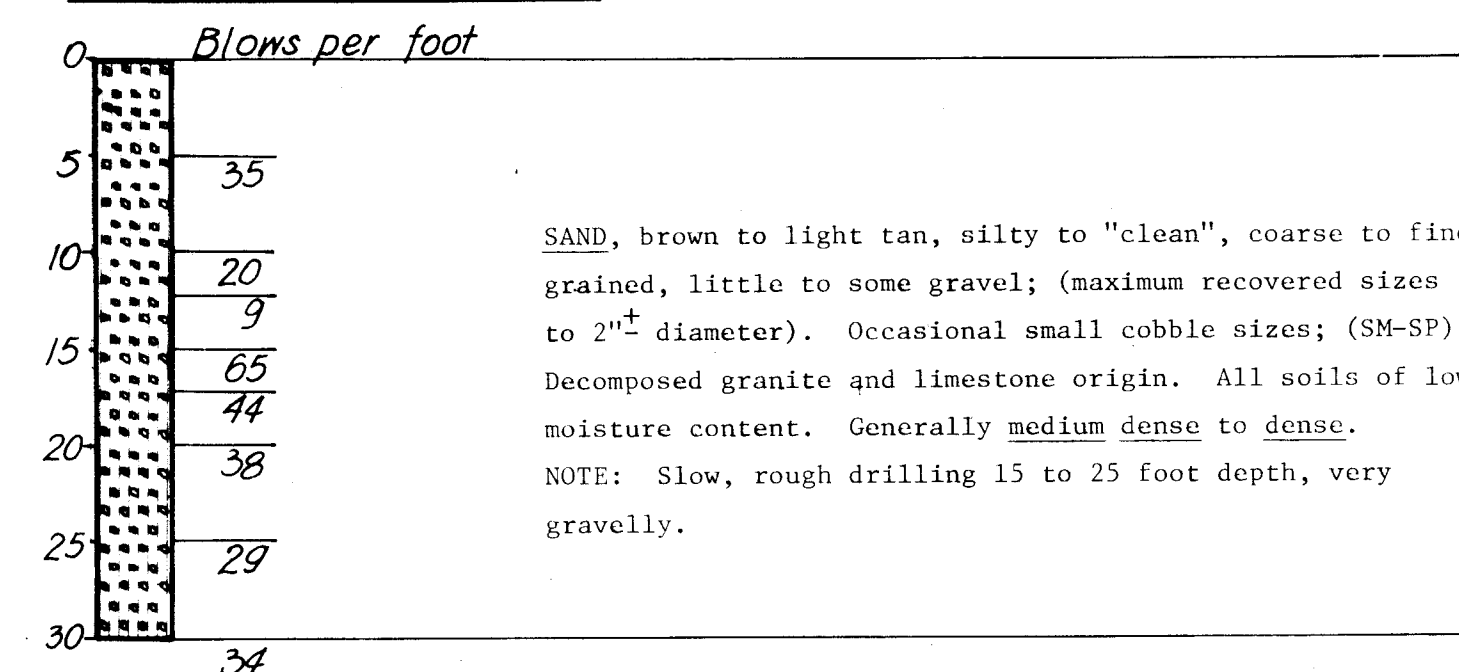

TEST HOLE # 4

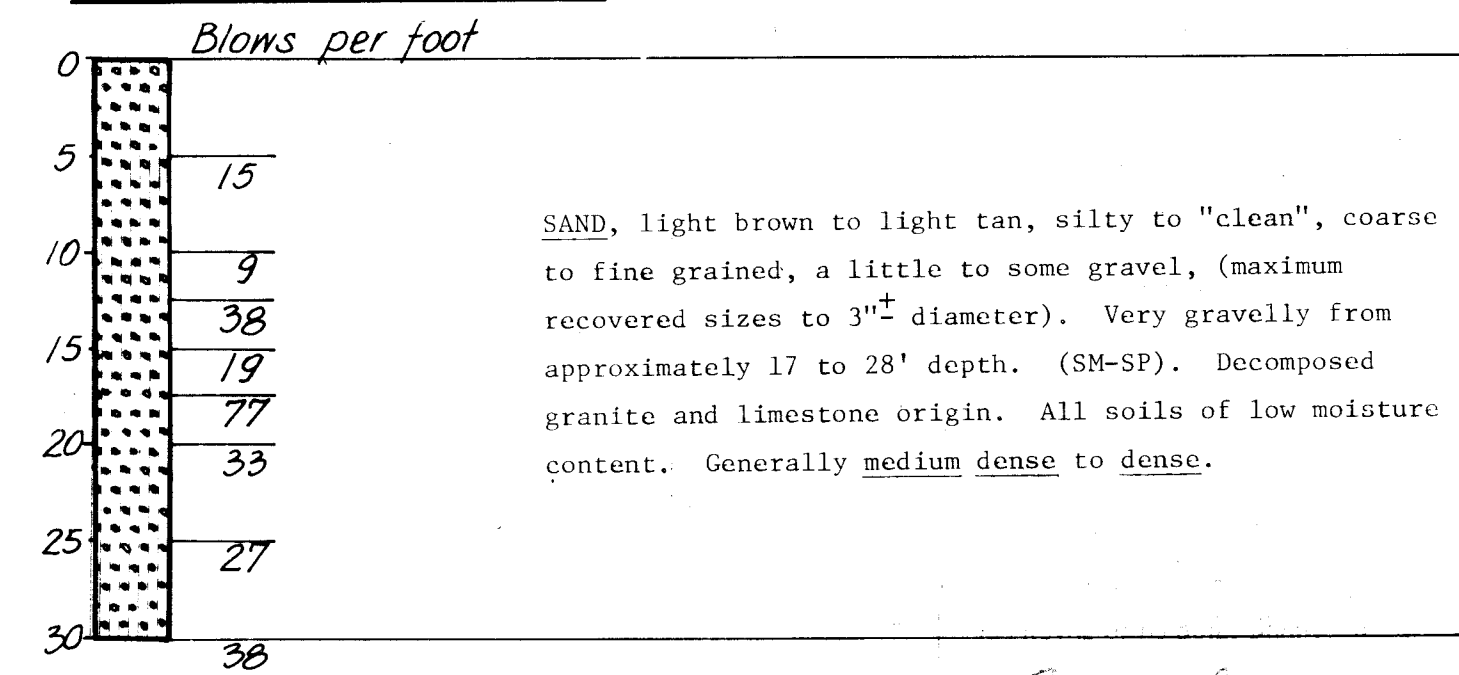

1 2 3 4 5 6 7 8 9 10 11 12
26 22 13 4 7 8 7 A

NOTE: Pay Links for Conc. Res. shall be 5'-0" outside of Ringwall


LAYOUT PLAN

RECORD DRAWING
FEB 8 1983

These drawings have been revised based on field data and every reasonable attempt has been made to depict construction as actually performed.

GRAPHIC SCALE

1"=30'

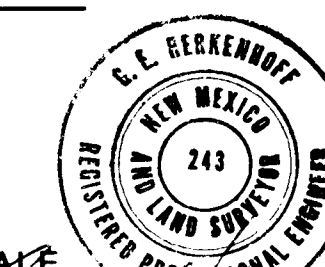


ALBUQUERQUE, NEW MEXICO

WALKER RESERVOIR

LOT NO. 2
CONCRETE RESERVOIR
SITE PLAN

GORDON HERKENHOFF & ASSOCIATES, INC.
ALBUQUERQUE ENGINEERS ARCHITECTS PLANNERS FARMINGTON SANTA FE

DRAWN BY
ERS
DATE
MAR, 1980
SCALE
1"=30'

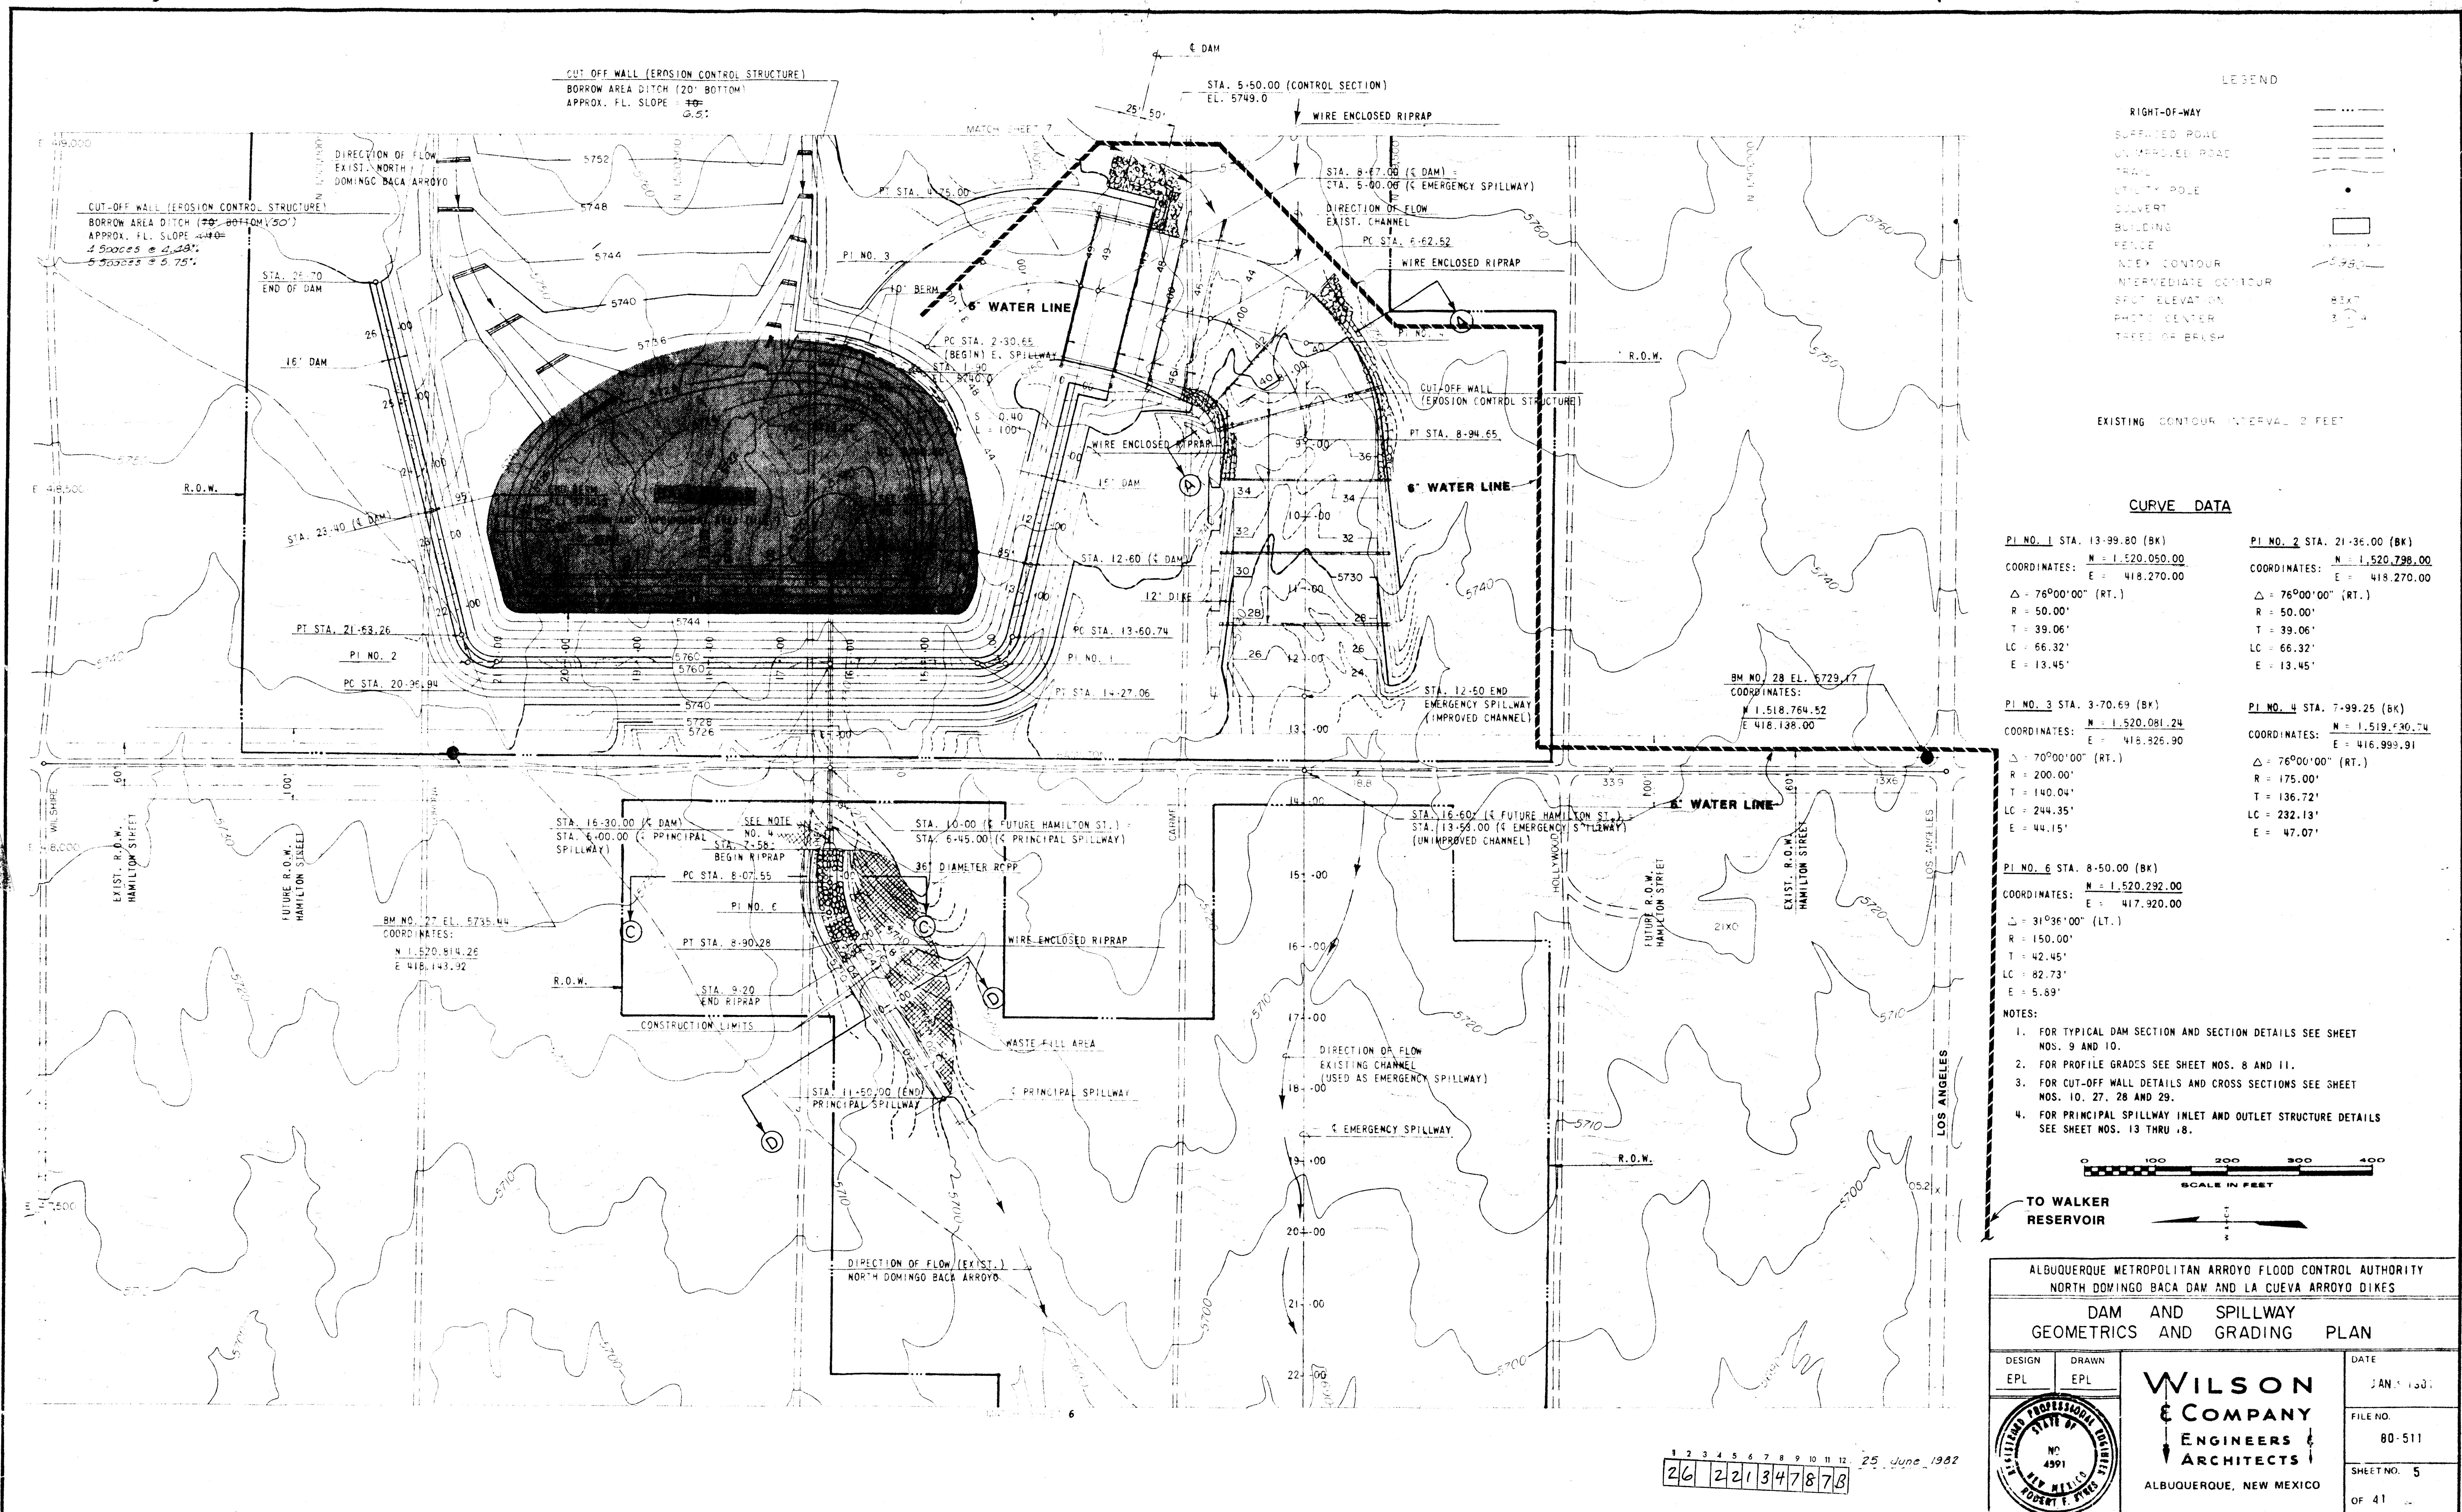

LEGEND

RIGHT-OF-WAY
SURFACED ROAD
UNIMPROVED ROAD
TRAIL
UTILITY POLE
CULVERT
BUILDING
FENCE
INDEX CONTOUR
INTERMEDIATE CONTOUR
SPOT ELEVATION
PHOTO CENTER
TREE OR BRUSH

EXISTING CONTOUR INTERVAL 2 FEET

CURVE DATA

PI NO. 1 STA. 13-99.80 (BK)
COORDINATES: N = 1,520,081.24
E = 418,270.00
Δ = 76°00'00" (RT.)
R = 50.00'
T = 39.06'
LC = 66.32'
E = 13.45'

PI NO. 2 STA. 21-36.00 (BK)
COORDINATES: N = 1,520,798.00
E = 418,270.00
Δ = 76°00'00" (RT.)
R = 50.00'
T = 39.06'
LC = 66.32'
E = 13.45'

PI NO. 3 STA. 3-70.69 (BK)
COORDINATES: N = 1,520,081.24
E = 418,270.00
Δ = 70°00'00" (RT.)
R = 200.00'
T = 140.04'
LC = 244.35'
E = 44.15'

PI NO. 4 STA. 7-99.25 (BK)
COORDINATES: N = 1,519,730.74
E = 416,999.91
Δ = 76°00'00" (RT.)
R = 175.00'
T = 136.72'
LC = 232.13'
E = 47.07'

PI NO. 5 STA. 8-50.00 (BK)
COORDINATES: N = 1,520,292.00
E = 417,920.00
Δ = 31°36'00" (LT.)
R = 150.00'
T = 42.45'
LC = 82.73'
E = 5.89'

ALBUQUERQUE METROPOLITAN ARROYO FLOOD CONTROL AUTHORITY
NORTH DOMINGO BACA DAM AND LA CUEVA ARROYO DIKES

DAM AND SPILLWAY
GEOMETRICS AND GRADING PLAN

| | | |
|--|--------------|----------------------|
| DESIGN
EPL | DRAWN
EPL | DATE
JAN. 1981 |
| | | FILE NO.
80-511 |
| WILSON & COMPANY
ENGINEERS & ARCHITECTS
ALBUQUERQUE, NEW MEXICO | | SHEET NO. 5
OF 41 |

26 221347878 25 June 1982