

LIST OF DRAWINGS


SHEET	TITLE
1	STORM SEWER - SECOND STREET
2	STORM SEWER - ROMA AVENUE
3	SANITARY SEWER - SECOND STREET
4	SANITARY SEWER - ROMA AVENUE SHEET 1
5	SANITARY SEWER - ROMA AVENUE SHEET 2

NOTES

1. Manholes shall be City of Albuquerque Standard, Type and Size as indicated.
2. Concrete for curbs and gutters shall have a compressive strength of 3000 psi at 28 days.
3. Where curbs and sidewalks are cut, remove the entire width to the nearest joint.
4. Bench mark on sidewalk at NE corner of 4th Street and Roma Ave. Elev. 4954.03
5. Contractor shall restore all pavement, curb and gutter and sidewalks removed or damaged by his operations.
6. Two lanes of traffic must be maintained on 2nd and 4th Streets, Roma Ave. and Marquette Ave.


LEGEND

- ① Sanitary Sewer Manhole
- ② Storm Sewer Manhole
- Street Light
- ⊕ Electric Manhole
- W— Water Line
- G— Gas Line
- S— Sanitary Sewer
- SS— Storm Sewer

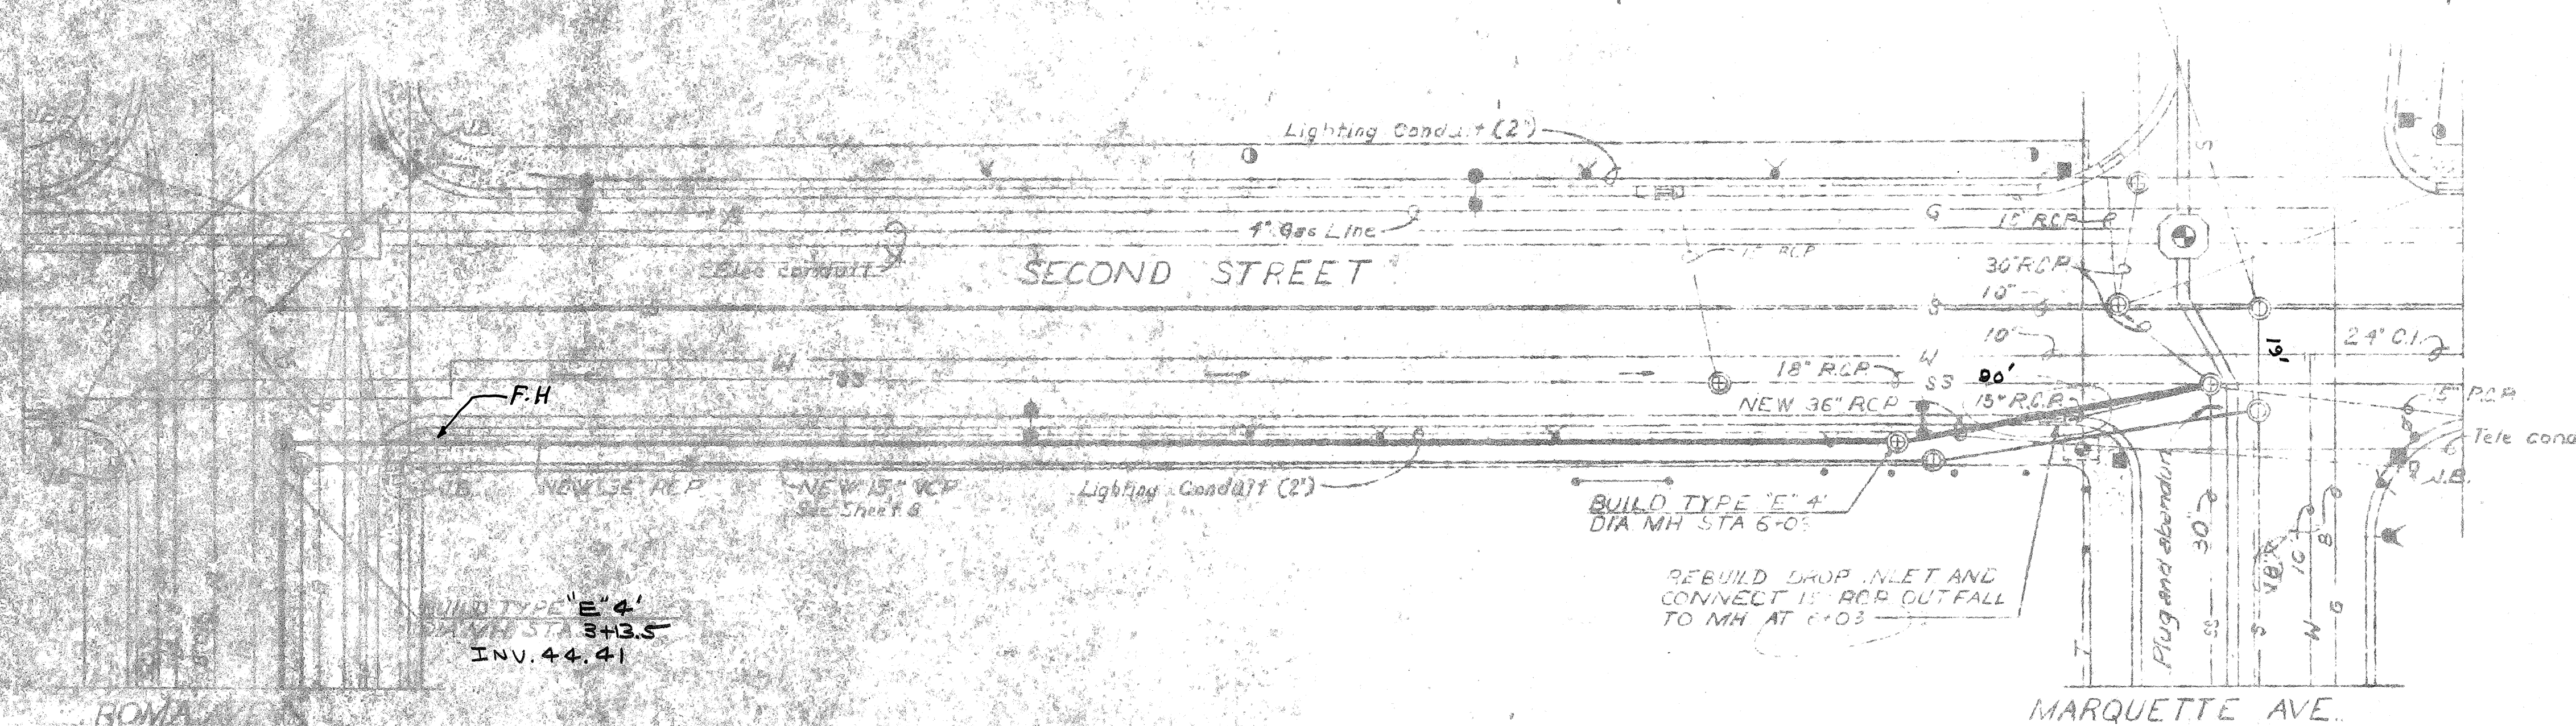

PLAN
Scale: 1"=20'

1	2	3	4	5	6	7	8	9	10	11	12	13	14	15	16	17	18	19	20	21	22	23	24	25	26	27	28	29	30	31
2	2		0	2	5		0	1	7	4				0	4									5	8	1	4	2	7	5

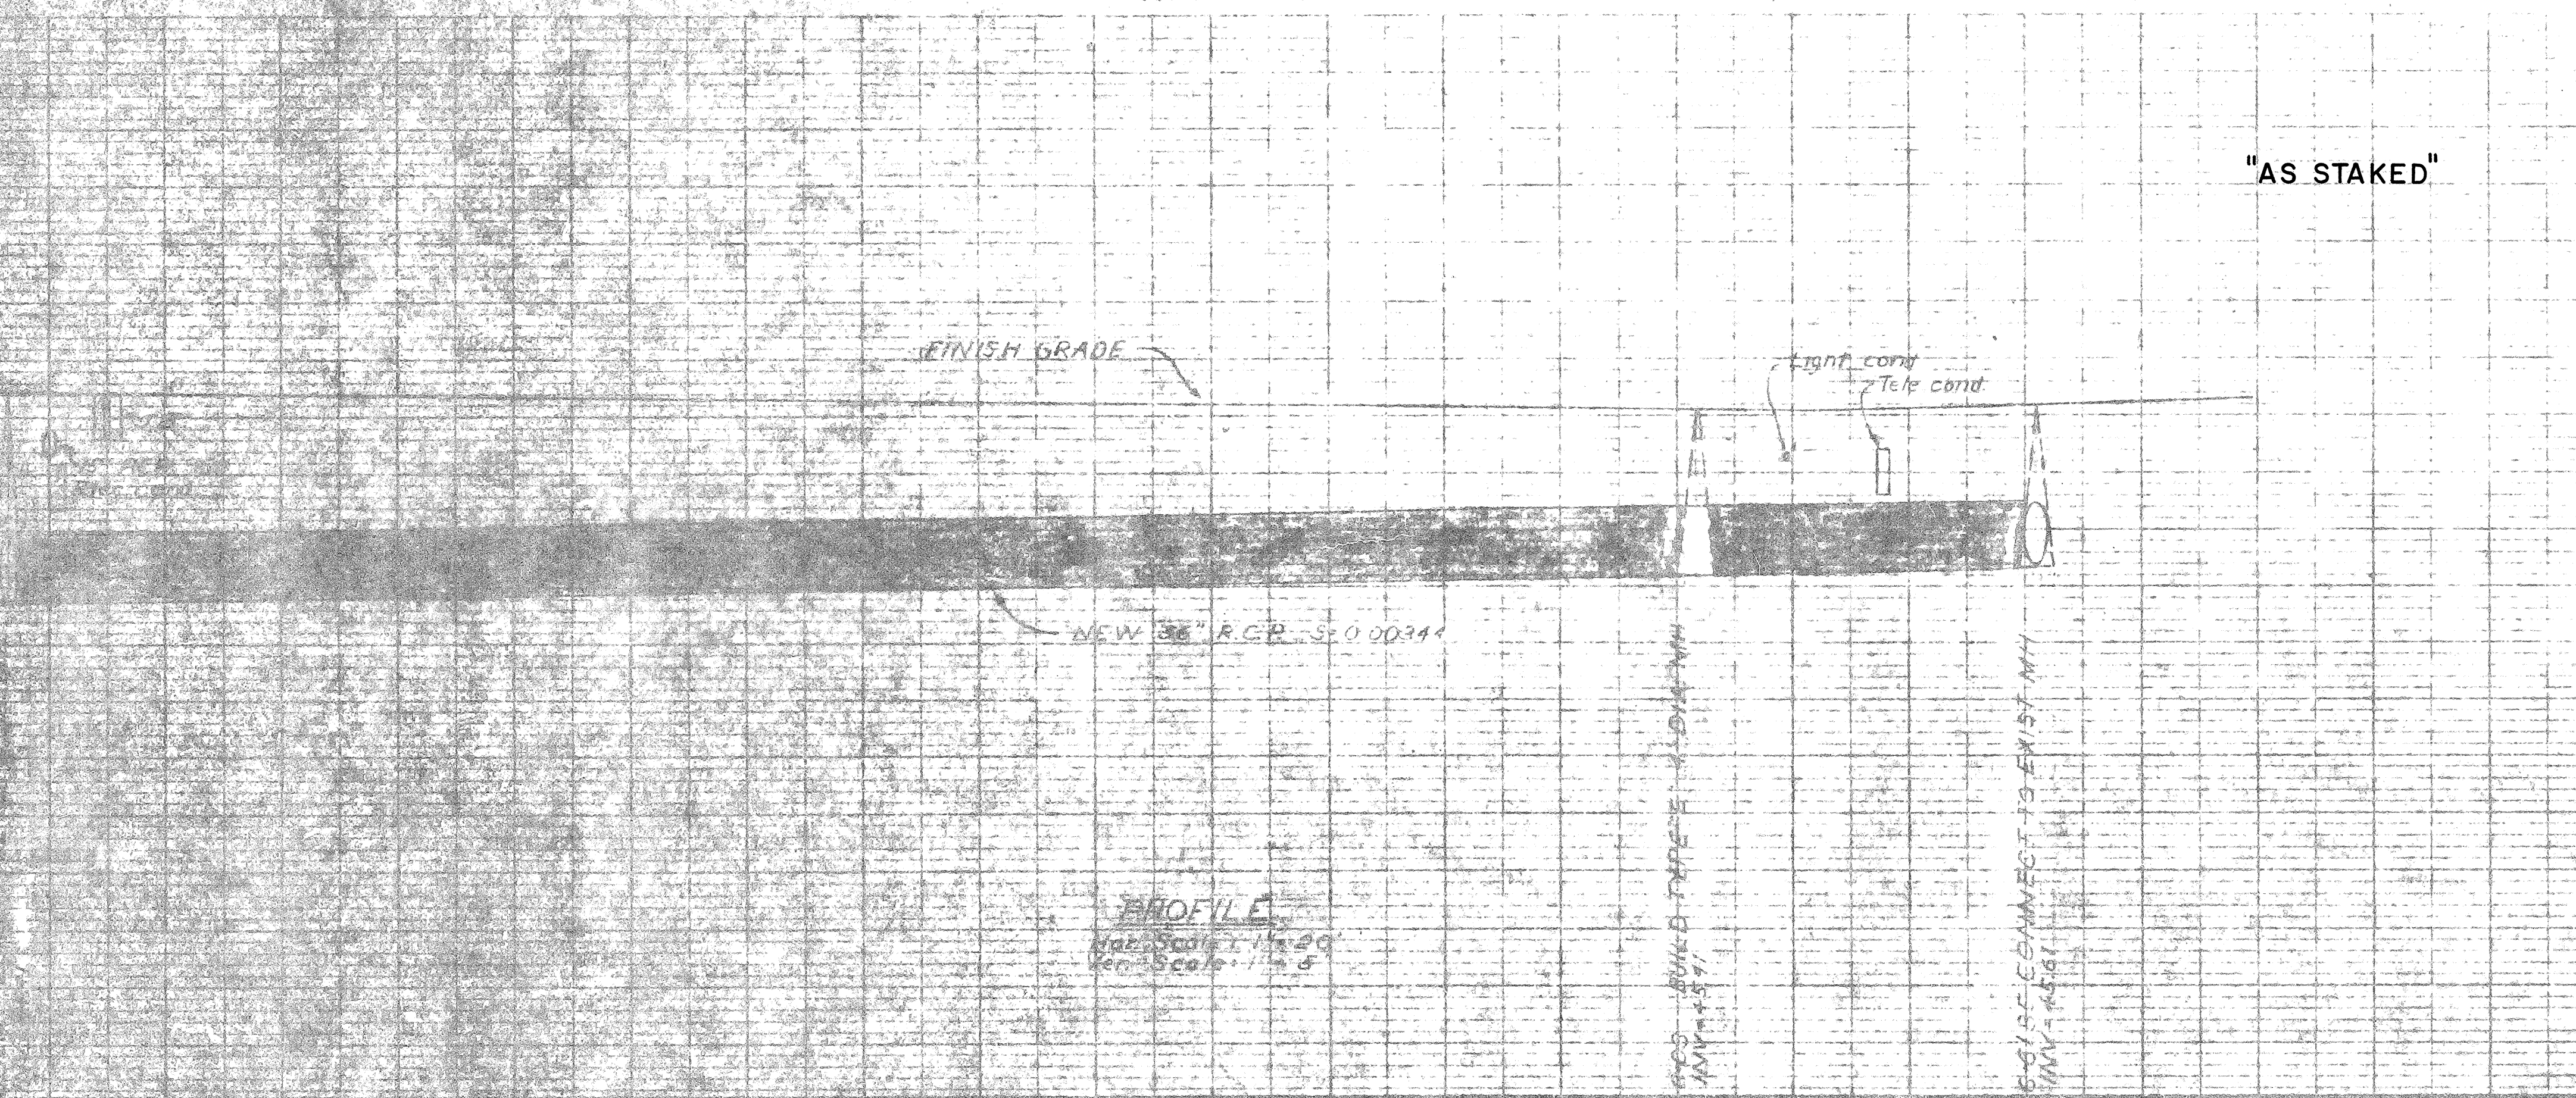

PROFILE
Scale: 1"=20'
Vertical Scale: 1"=5'

"AS STAKED"


4955
4950
4945
4940

J-14

NO.	DATE	DESCRIPTION	BY	APPD.
SVERDRUP & PARCEL AND ASSOCIATES, INC. ENGINEERS - ARCHITECTS SAN FRANCISCO, CALIFORNIA				
UTILITIES RELOCATION CITY OF ALBUQUERQUE STORM SEWER - SECOND STREET PLAN AND PROFILE				
SCALE AS SHOWN	DESIGNED J.V.H.	DRAWN C.W.C.	CHECKED C.W.C.	DATE 7-25-74
SUBMITTED [Signature] SVERDRUP & PARCEL AND ASSOCIATES, INC. APPROVED [Signature]			DRAWING NO. EPI 7401-14 SHEET 1	

SS-25-74


Disb. 8-15-74

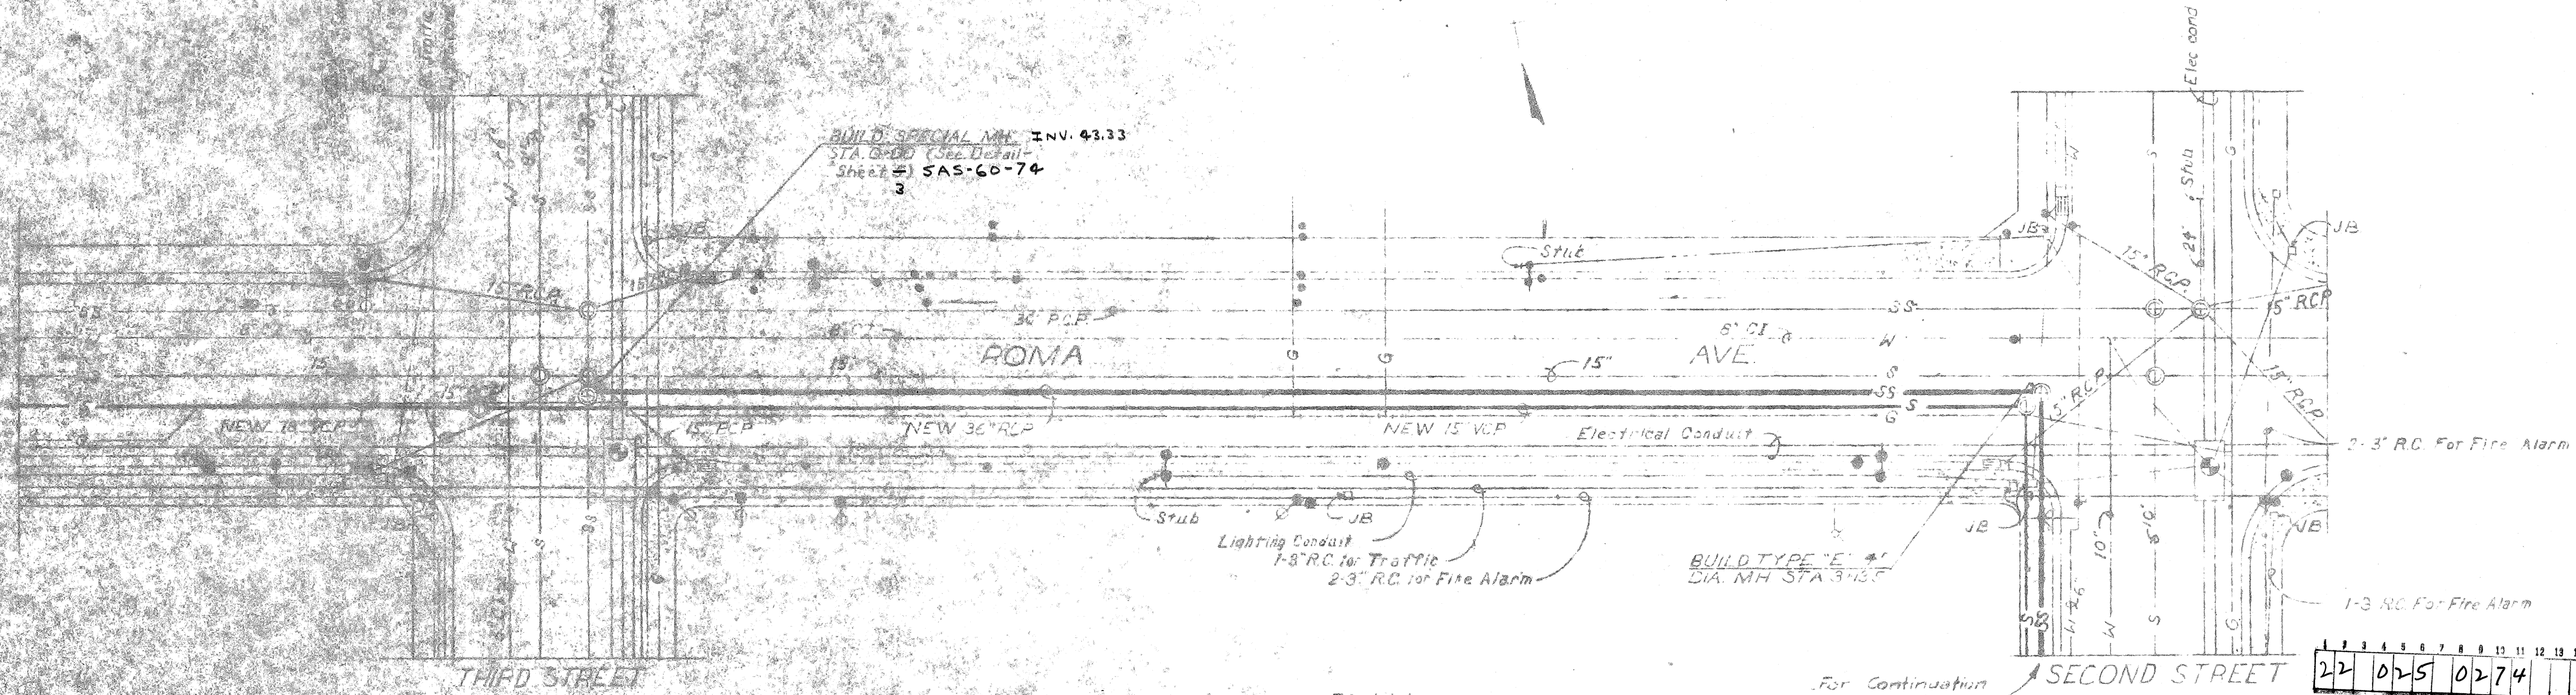

PLAN
Scale: 1" = 20'

For Continuation
See Sheet 1

1	2	3	4	5	6	7	8	9	10	11	12	13	14	15	16	17	18	19	20	21	22	23	24	25	26	27	28	29	30	31
22	025	0274													04															

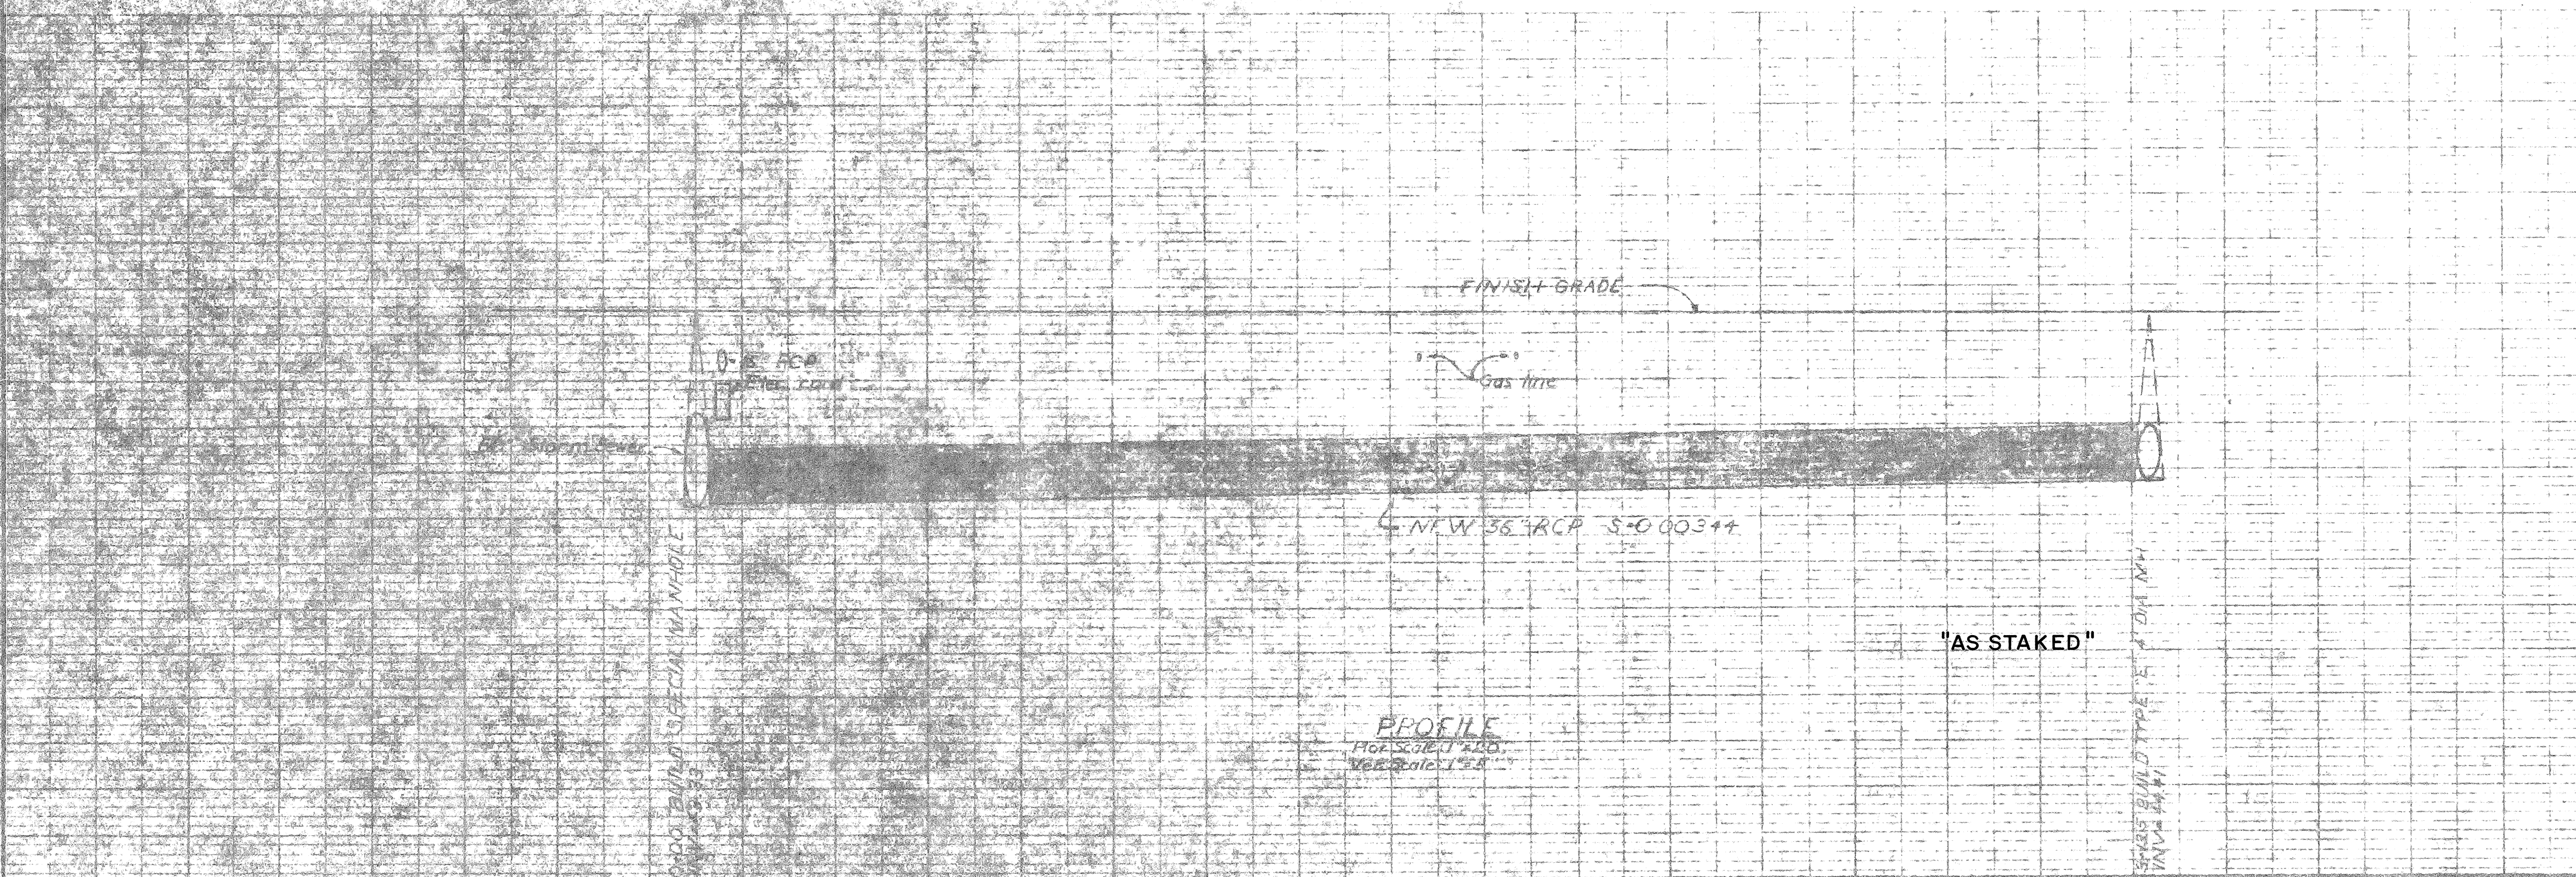

Stationing along New Storm Sewer line

4955
4950
4945
4940

J-14

REVISION	DATE	DESCRIPTION	BY	APPD
SVERDRUP & PARCEL AND ASSOCIATES, INC. ENGINEERS - ARCHITECTS SAN FRANCISCO, CALIFORNIA				
UTILITIES RELOCATION CITY OF ALBUQUERQUE STORM SEWER - ROMA AVE. PLAN AND PROFILE				
SCALE	AS SHOWN	SUBMITTER	DATE 7-29-74	
DESIGNED	JVH	SVERDRUP & PARCEL AND ASSOCIATES, INC.		DRAWING NO.
DRAWN	CWC	APPROVED		FPI 7401-10
CHECKED	WWS			SHEET 2

SS-25-74