


CONSTRUCTION PLANS FOR

LOWER ZONE 9E 14"

MASTERPLAN WATERLINE

MANITOBA DR. NE AND CALLE DE CARINO NE TO PEPPERTREE SUBDIVISION

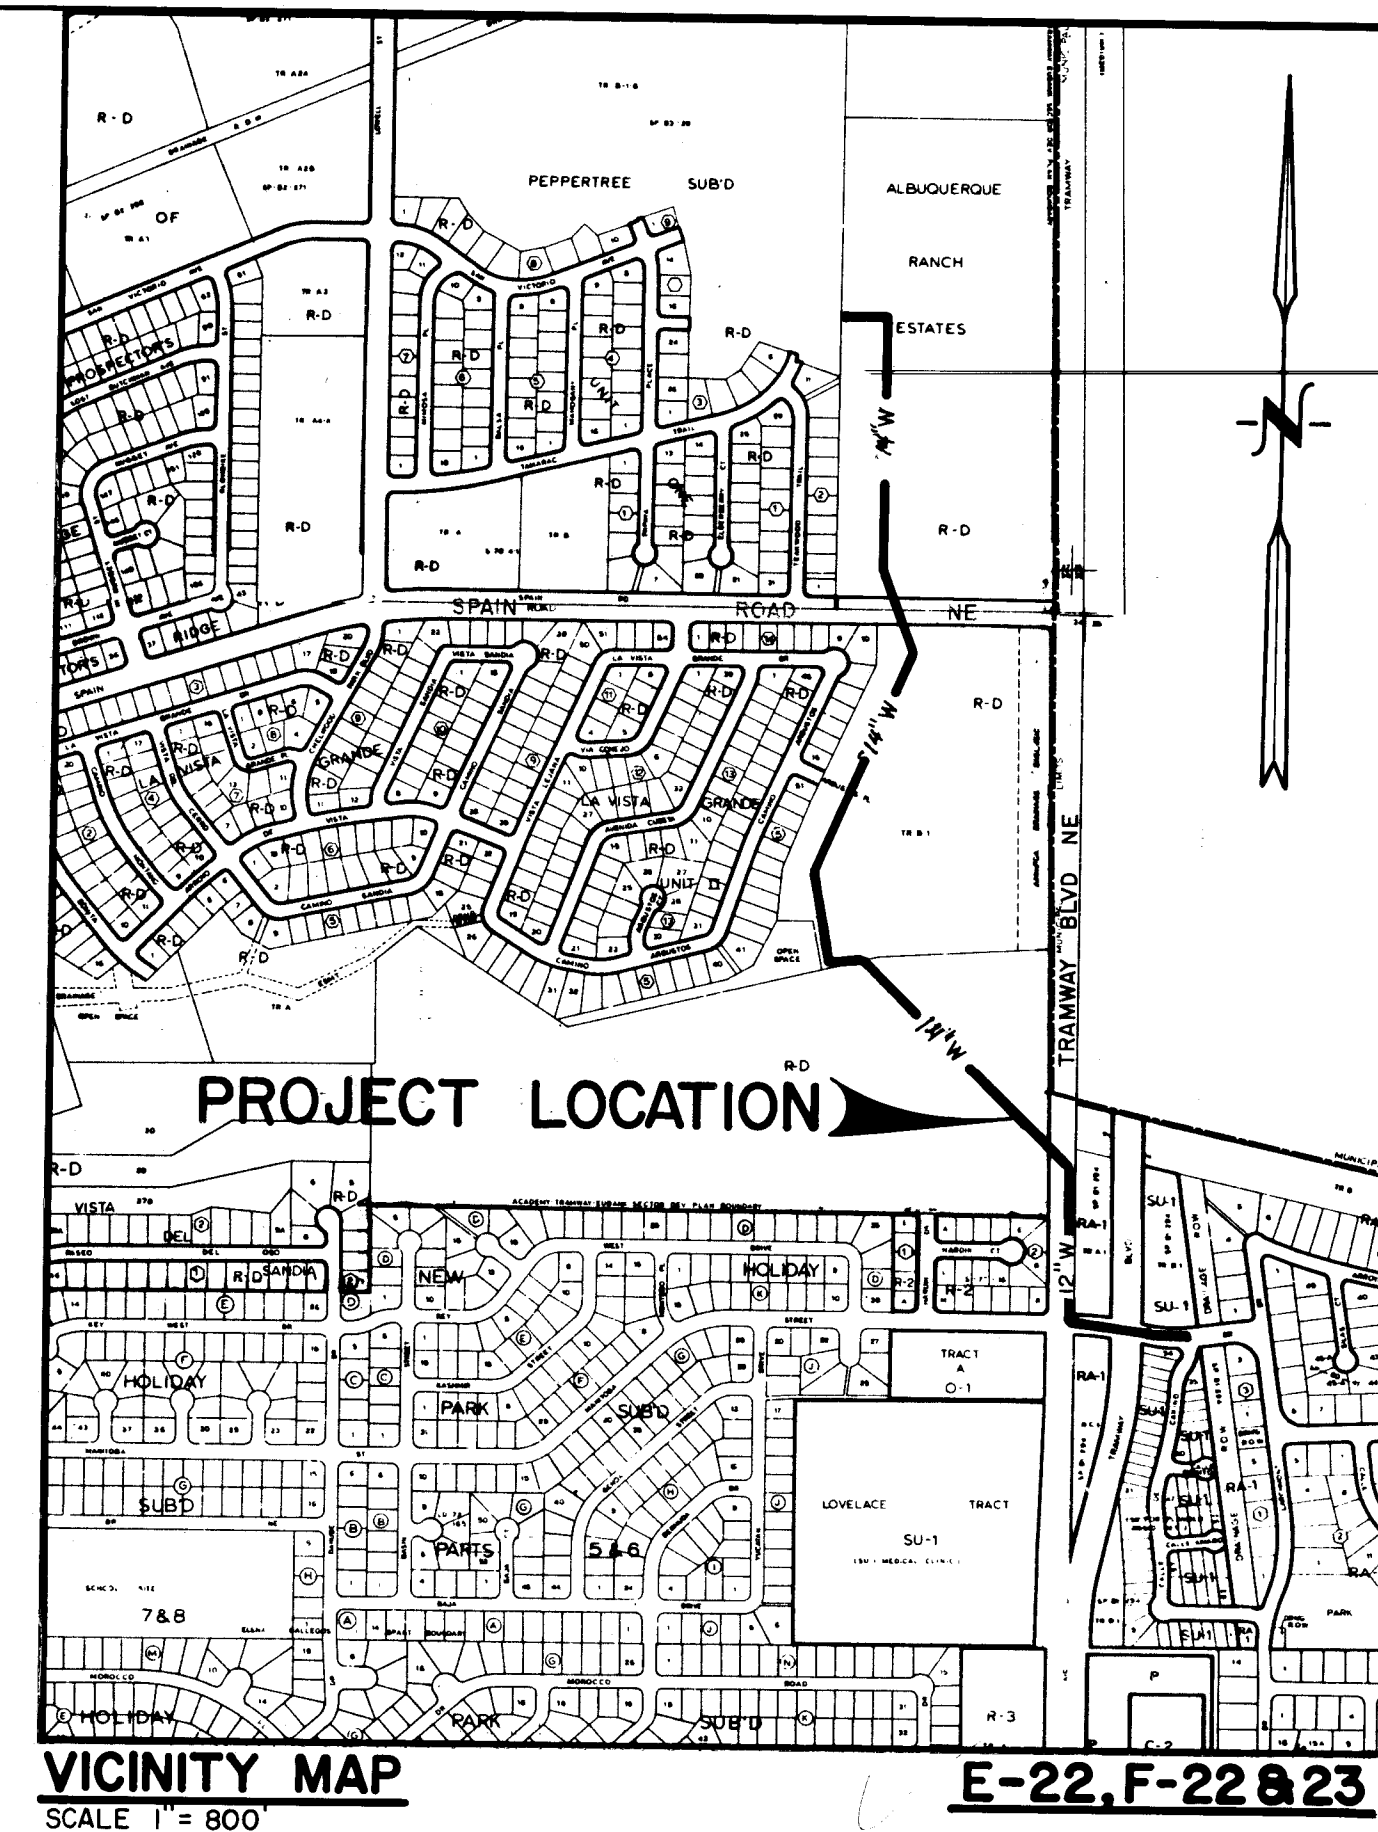

VICINITY MAP
SCALE 1" = 800'

E-22, F-22 & 23


INDEX TO DRAWINGS

SHEET NO.	DESCRIPTION
1	COVER SHEET, GENERAL NOTES
2	OVERALL WATER LINE PLAN
<u>PLAN AND PROFILE</u>	
3	W STA 0+00.00 TO W STA 22+62.30
4	W STA 22+62.30 TO W STA 37+38.30
5	ROYAL OAK AVENUE NE $\pm$ STA 0+00.00 TO $\pm$ STA 7+50.00
6	ROYAL OAK AVENUE NE $\pm$ STA 7+50.00 TO $\pm$ STA 13+53.32
7	TRAFFIC CONTROL PLAN

GENERAL NOTES

- All work detailed on these plans to be performed under this contract shall be constructed in accordance with the City of Albuquerque Interim Standard Specifications for Public Works Construction - 1985 Edition (referred herein as the Standard Specification) and the Supplemental Specifications of this project unless otherwise noted in the contract documents.
- Two (2) working days prior to any excavation, Contractor must contact line locating service, 765-1234, for location of existing utilities.
- Prior to construction, the Contractor shall excavate and verify the horizontal and vertical locations of all potential obstructions. Should a conflict exist, the Contractor shall notify the Engineer so that the conflict can be resolved with a minimum amount of delay.
- All work on this project shall be performed in accordance with applicable Federal, State and Local laws, rules, and regulations concerning construction safety and health.
- Contractor shall maintain access to adjacent properties during construction.
- All gas, electric, telephone lines, cables, and appurtenances encountered during construction that require relocation, shall be done by the responsible utility. Contractor shall be responsible for coordination of all necessary utility adjustments.
- It will be the Contractor's responsibility to protect and maintain in service all existing utilities.
- The Contractor will be required to confine his work within the construction limits and/or public right-of-way to preserve existing vegetation and private property. Overnight parking of construction equipment shall not obstruct driveways or designated traffic lanes.
- A disposal site for all excess excavation material, asphaltic paving, concrete curbs and sidewalks, etc., shall be obtained by the Contractor in compliance with applicable environmental regulations and approved by the Field Engineer. All costs incurred in obtaining a disposal site and haul thereto shall be considered incidental to the project and no separate measurement or payment shall be made.
- Where removal of existing curbs and gutters, sidewalk or pavement is required, Contractor shall sawcut and/or remove to the nearest joint. Curb and gutter shown on these plans as existing and not to be removed under this contract, which is damaged or displaced by the Contractor shall be removed and replaced at the Contractor's expense.
- When abutting new pavement to existing, sawcut existing pavement to a straight edge and at a right angle, or as approved by the Project Engineer, to remove any broken or cracked pavement.
- All stationing shown on these plans is based on street centerline or centerline of pipe unless noted otherwise.
- The Contractor must submit a construction signing and barricading plan to Traffic Engineering prior to construction to receive a barricading permit.
- Backfill compaction shall be according to specified street use.
- All trench backfill shall be compacted to a minimum 90% maximum density as per ASTM -D1557.
- Any existing utility service lines that do not require relocation and are damaged by the Contractor shall be removed and replaced at the Contractor's expense. This expense shall be considered incidental to the project and no separate payment shall be made.

REV.	SHEETS	CITY	ENGR.	DATE	USER	DEPT.	DATE	USER	DEPT.	DATE
APPROVAL OF REVISIONS										

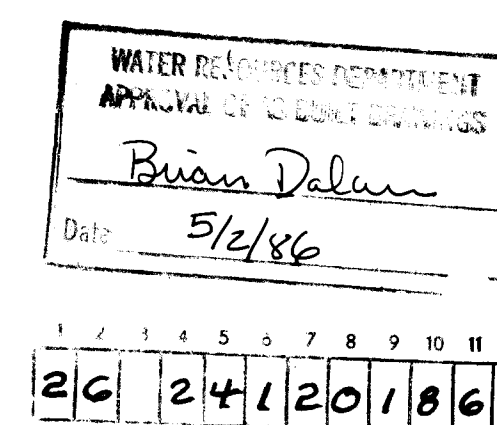


26 24120186

ENGINEERS SEAL 	ESPEY, HUSTON & ASSOC., INC. Engineering & Environmental Consultants 4801 INDIAN SCHOOL ROAD N.E. SUITE 204 ALBUQUERQUE, NEW MEXICO 87110 PHONE (505) 255-1625	APPROVED FOR CONSTRUCTION
PROJECT NUMBER 2412		SHEET 1 OF 7




1	2	3	4	5	6	7	8	9	10	11	12
26		24	1	2	0	2	8	6			



DRAWING NO	2412	MAP NO. E-22,F-22,23	SHEET 2 OF 7
---------------	------	-------------------------	--------------

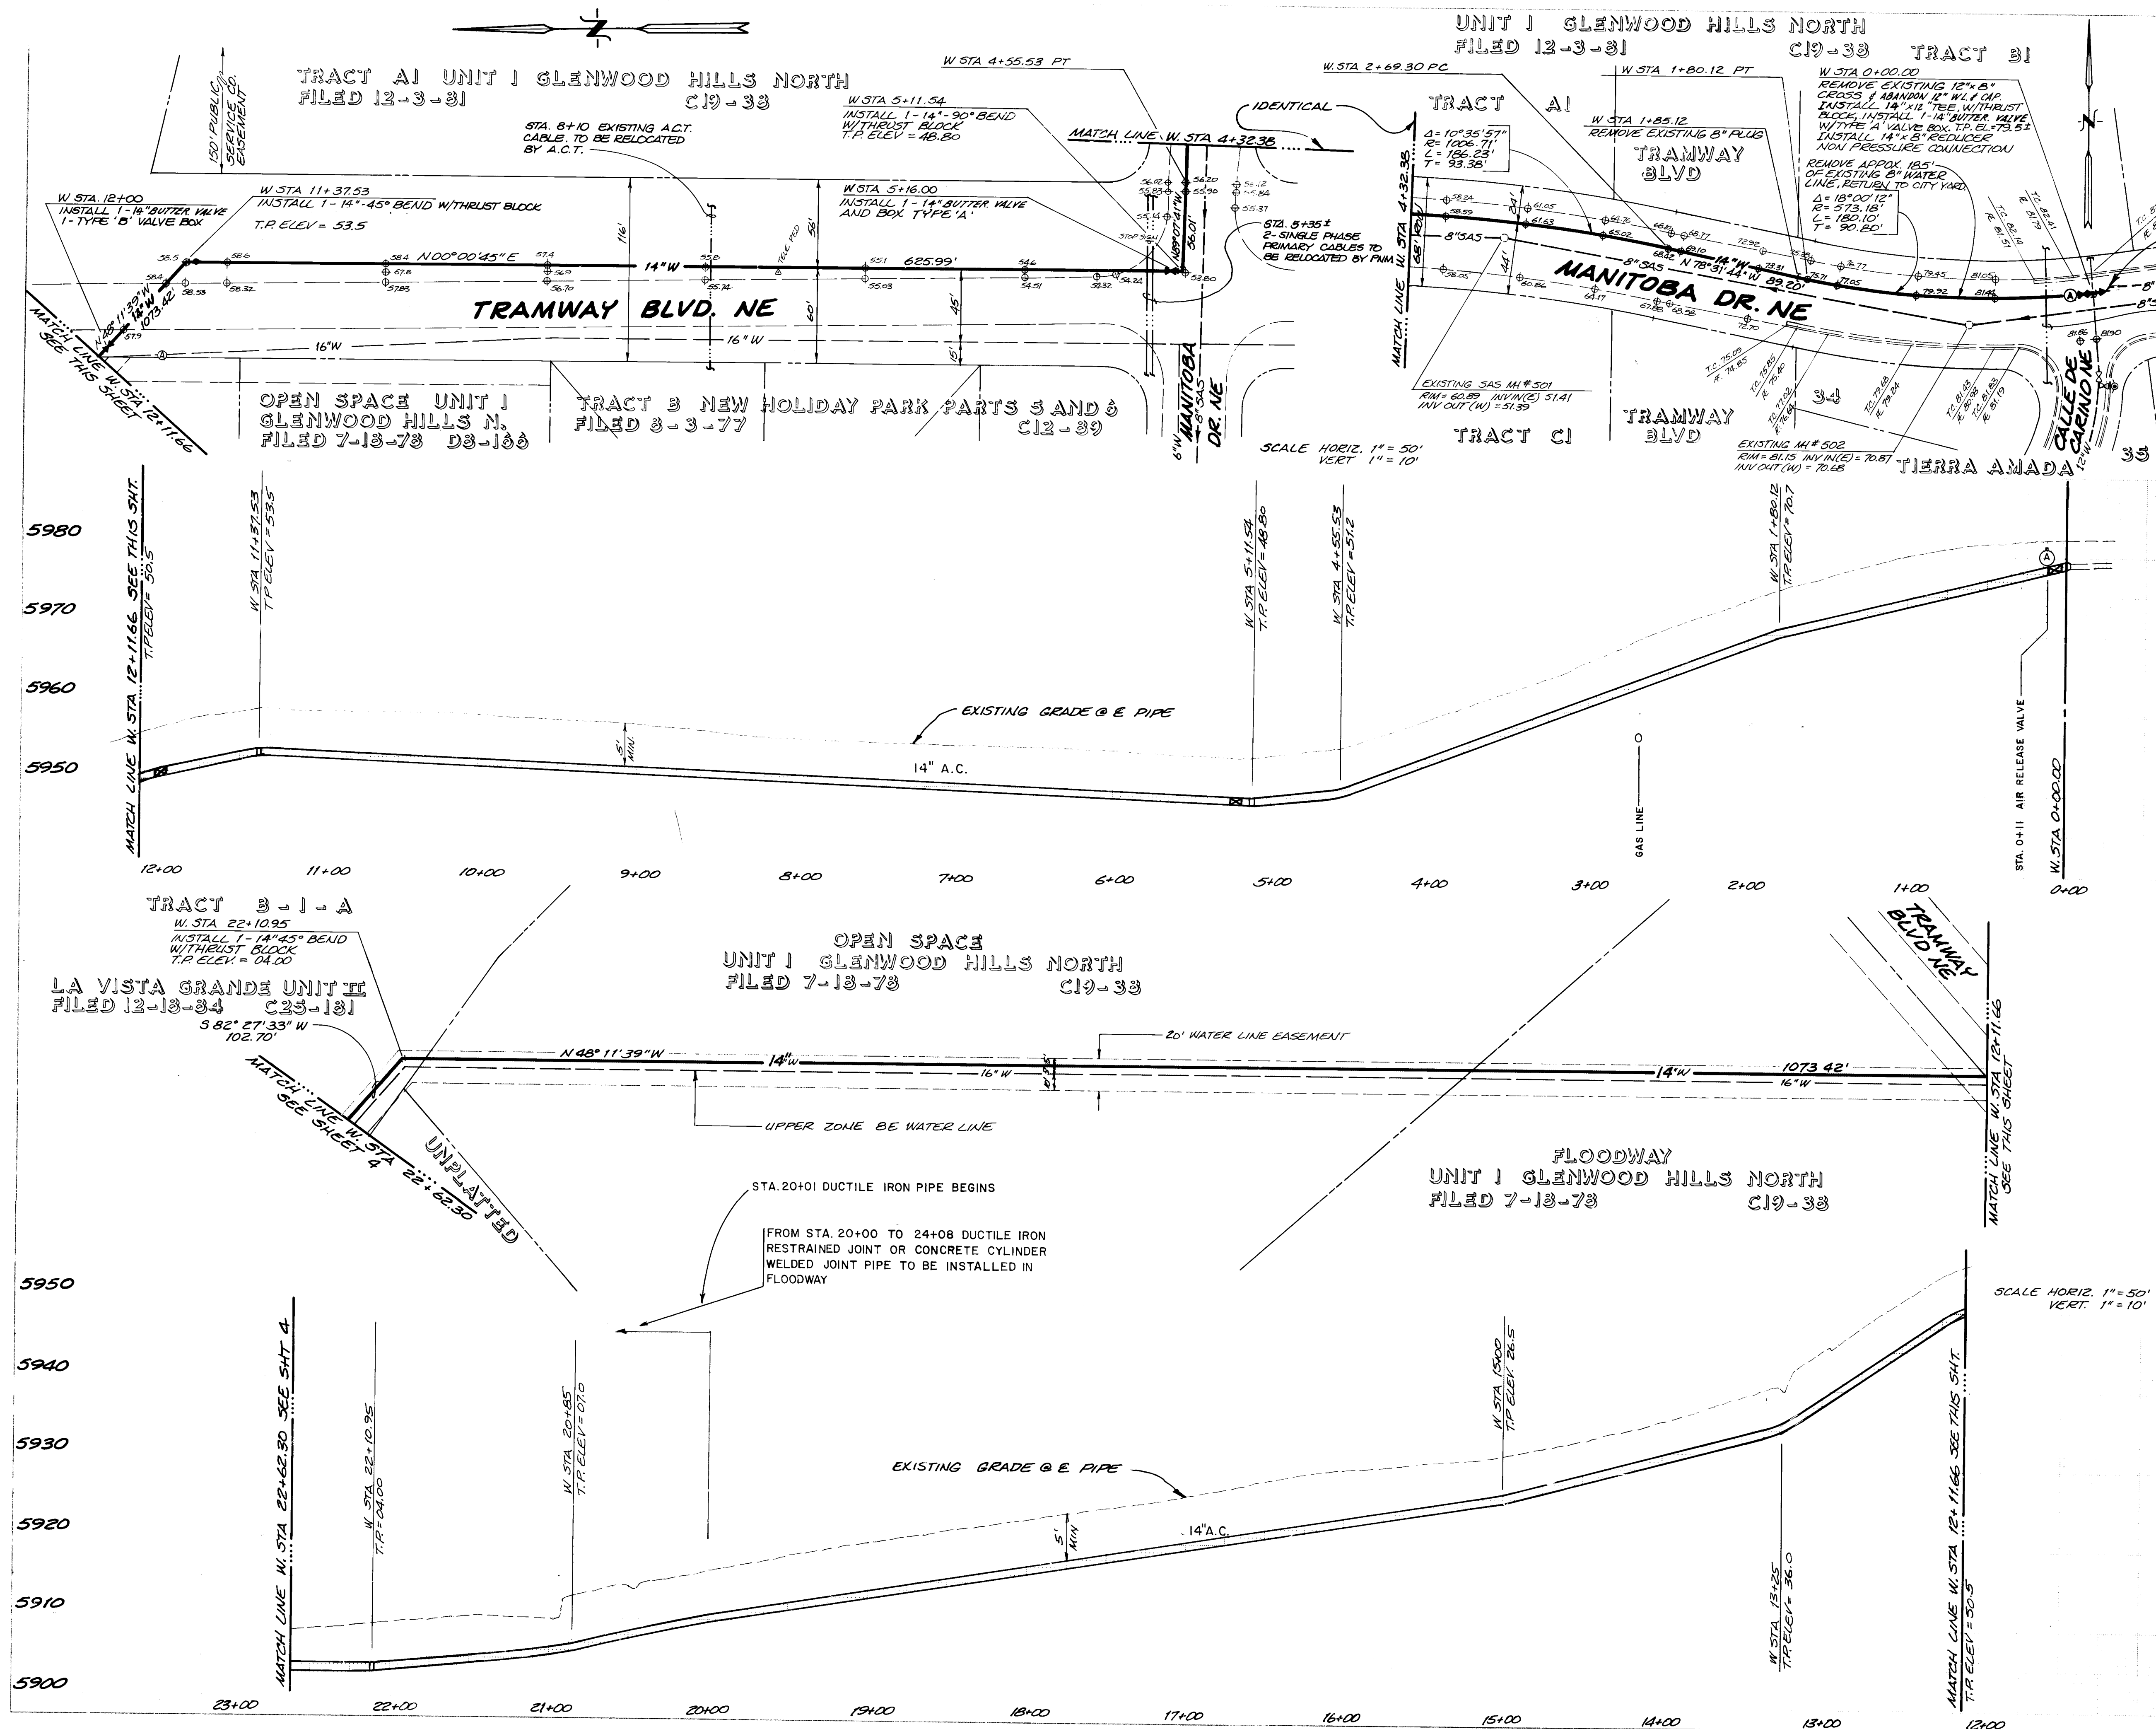

AS BUILT INFORMATION	
NEW CONCRETE 12\"/>	
BENCH MARKS ACS BENCH MARK 1-F22 LOCATED AT THE INTERSECTION OF TRAMWAY BLVD. NE AND MANITOBA ST. NE. THE STATION IS ON THE NORTHSIDE OF MANITOBA ST., 100 FEET WEST OF THE ROAD JUNCTION. THE STATION MARK IS A STANDARD ACS BRASS TABLET, STAMPED "1-F22", SET IN TOP OF A CONCRETE POST PROJECTING 0.3 FT. ABOVE GROUND. ELEVATION = 5957.02 FEET (MSLD).	
SURVEY INFORMATION	
NO.	DATE
FIELD NOTES	
BY	
ENGINEER'S SEAL	
5/1/85	
REMARKS	
NO.	DATE
REVISIONS	
DESIGN	DATE
TXW	JAN 1985
TXW	JAN 1985
DAL	2-11-85
ESPEY, HUSTON & ASSOC., INC. Engineering & Environmental Consulting 2624 24th Avenue, N.E. Albuquerque, N.M. 87110 26 241 20386	
CITY OF ALBUQUERQUE MUNICIPAL DEVELOPMENT DEPARTMENT ENGINEERING DIVISION	
TITLE LOWER ZONE 9E-14" WATER LINE W STA 0+00.00 TO W STA 22+62.30	
APPROVAL	ENGINEER
DATE	DATE
APPROVAL	DATE
City Engineer	9/1/85
ACE Design	NA DPH 11/1/85
ACE Hydrology	NA DPH 9/1/85
DRAWING NO. 2412	
MAP NO. F-22,23	
SHEET 3 OF 7	

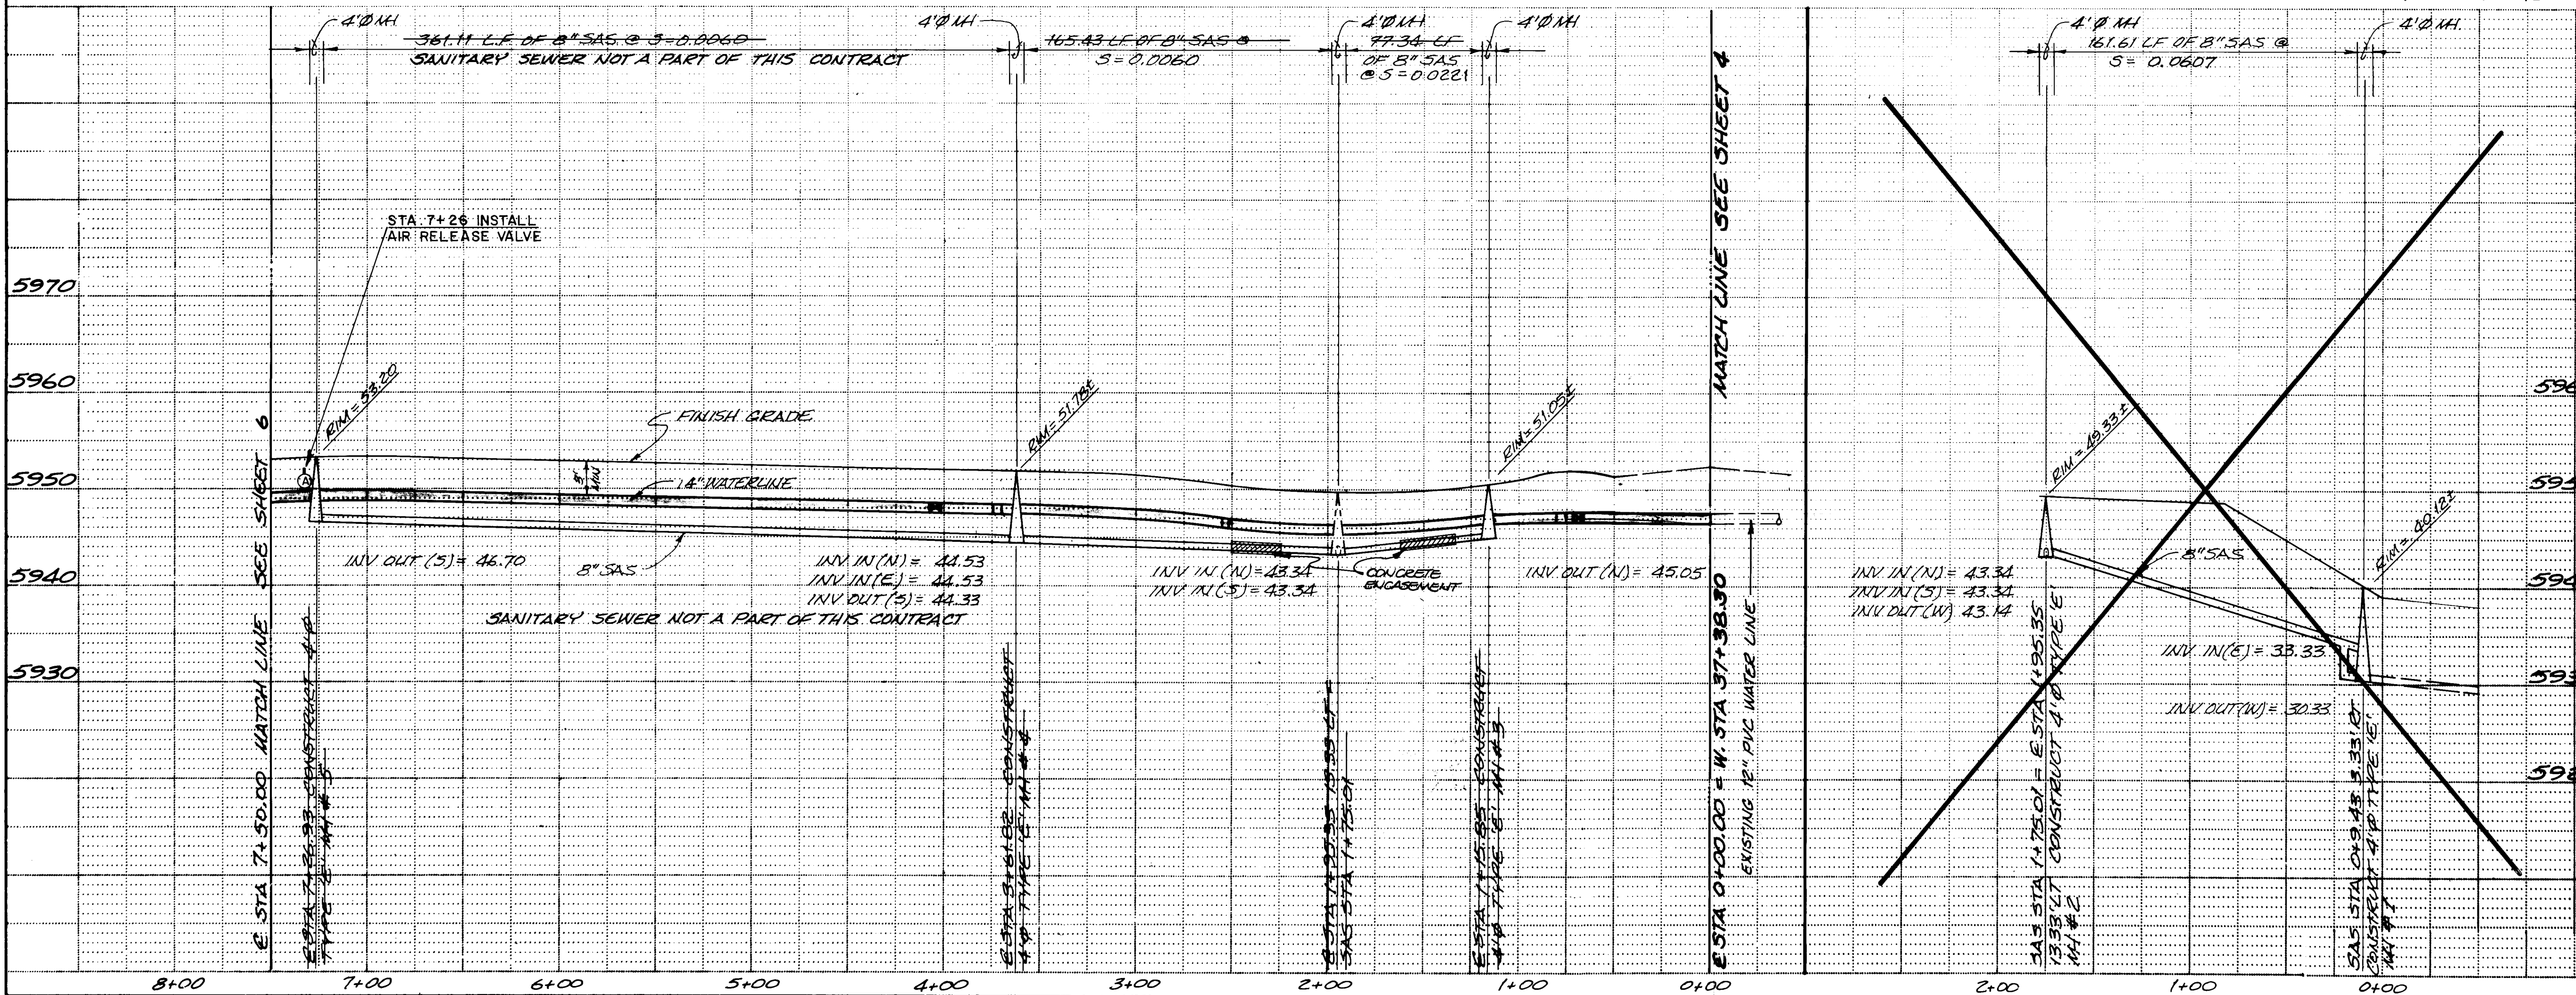

1 2 3 4 5 6 7 8 9 10 11 12 26 24120586		13 14 15 1000		101 102 103 104 105 106 107 108 109 110 111 112 113 114 115 116 117 118 119 120 121 122 123 124 125 126 127 128 129 130 131 132 133 134 135 136	
---	--	---	--	---	--

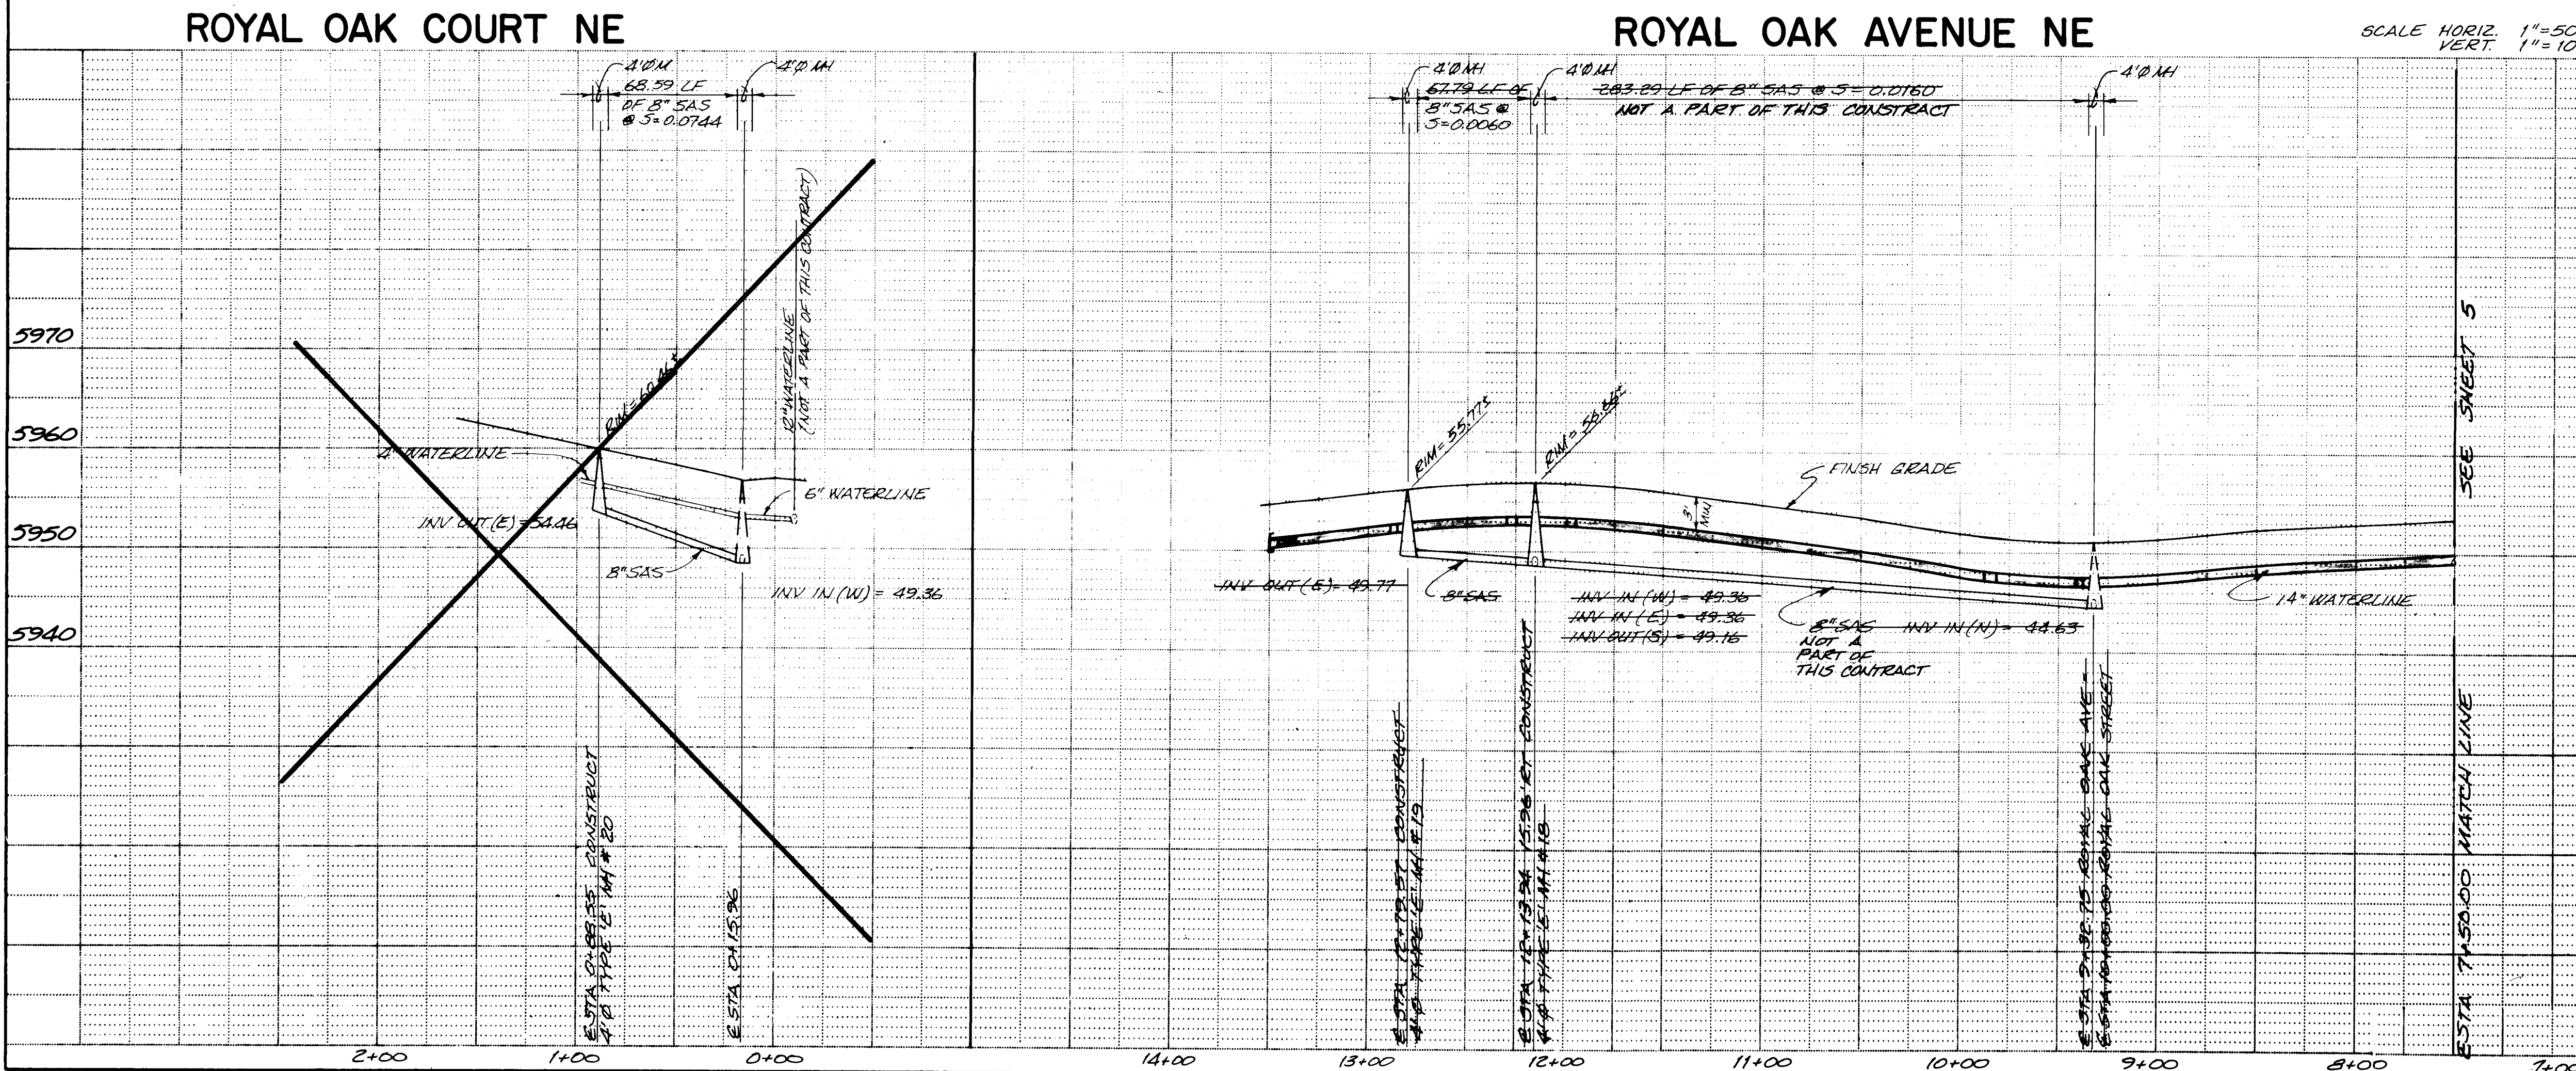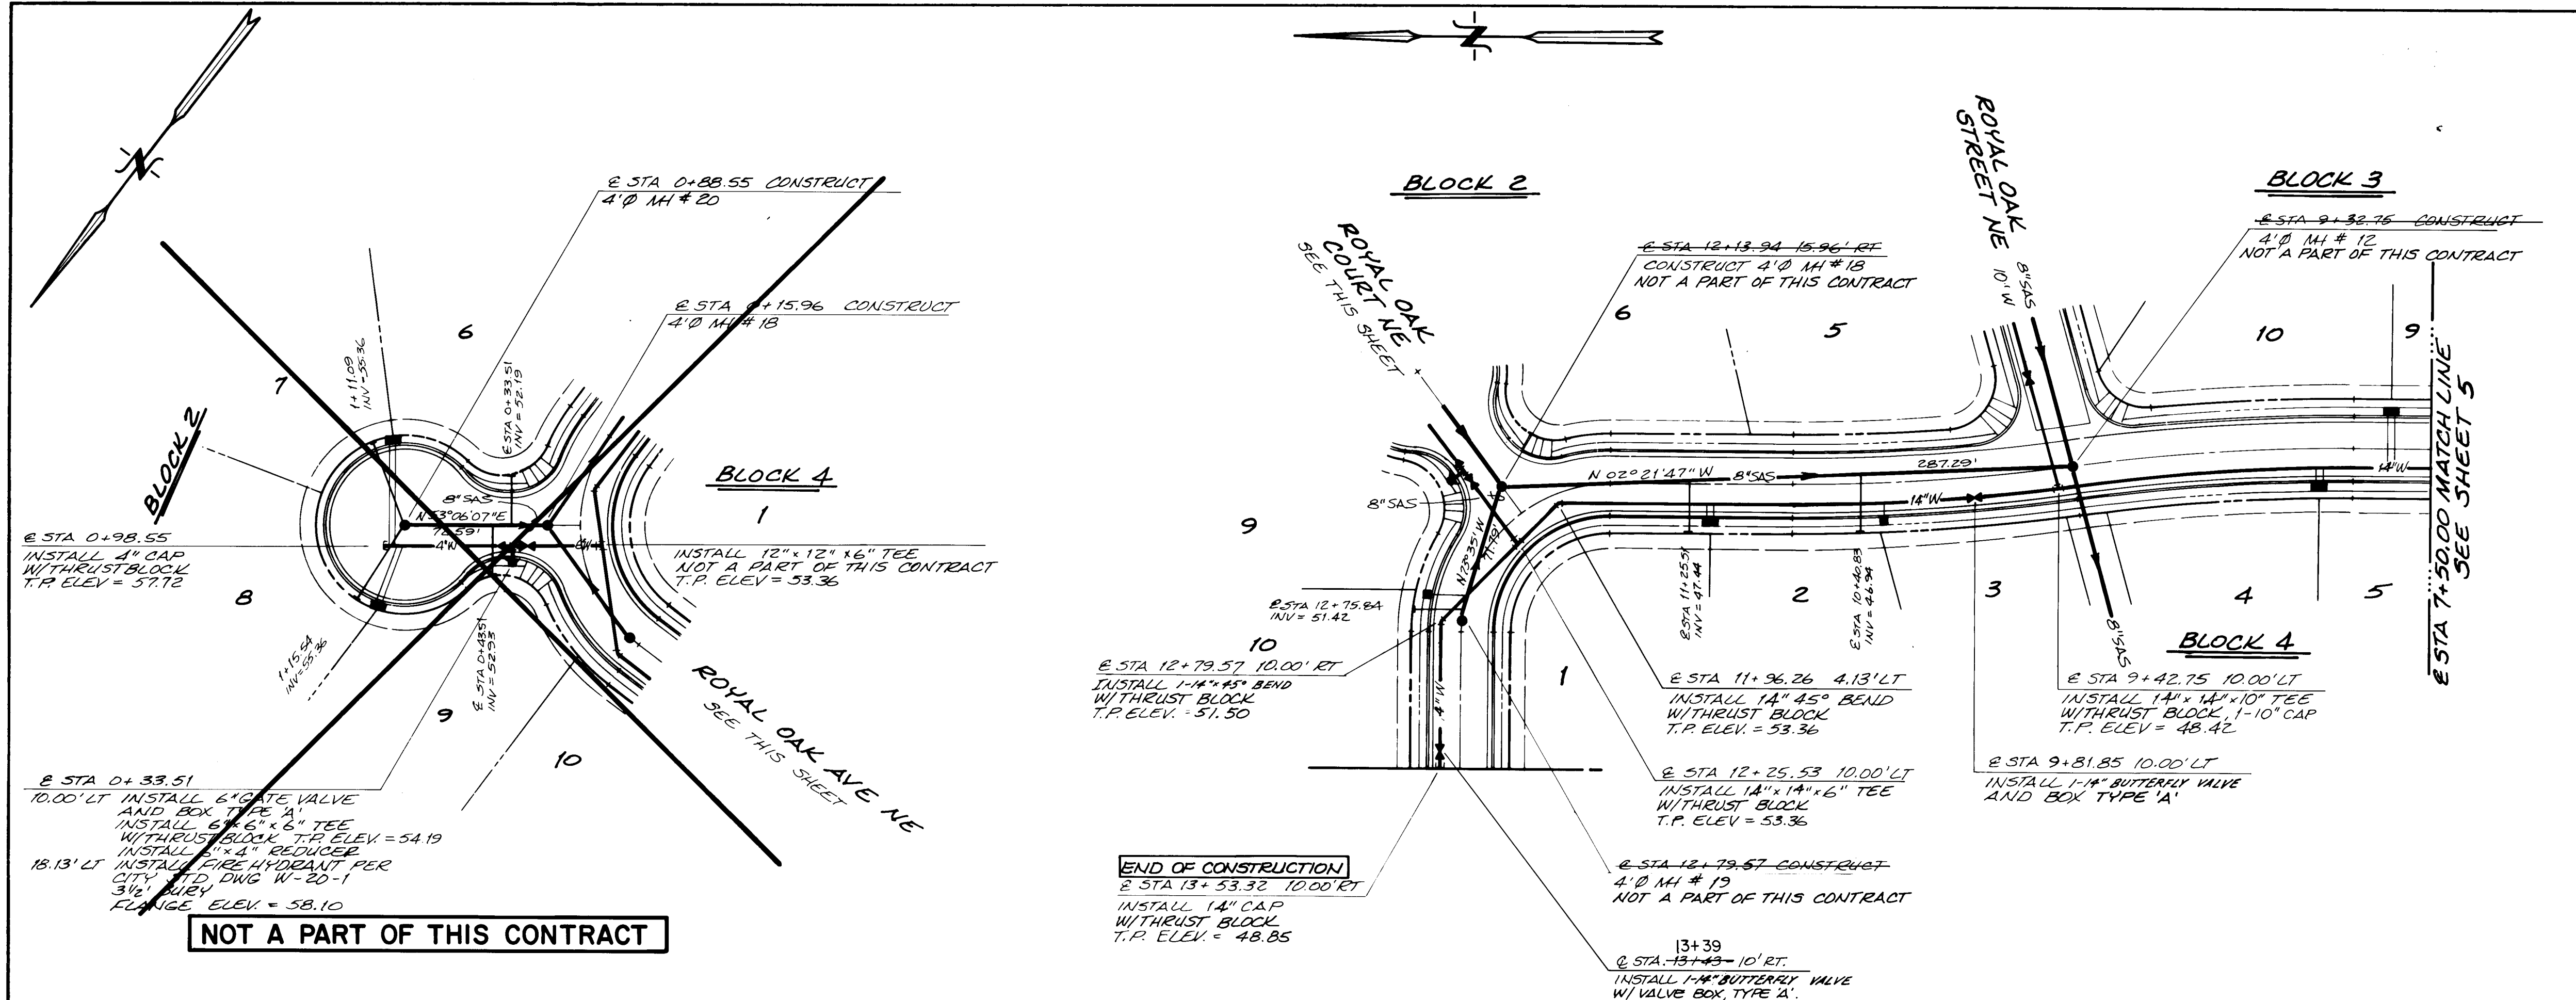

- NOTES:
- 1) ALL WATER LINE AND SANITARY SEWER IS BASED ON CENTER LINE OF THE STREET UNLESS NOTED OTHERWISE.
 - 2) THE FOLLOWING CITY OF ALBUQUERQUE STANDARD DETAIL DRAWINGS FOR THE WATER LINE AND SANITARY SEWER LINE CONSTRUCTION ARE APPLICABLE.

W-1-3	5-2-4
W-2-3	5-3-2
W-4-1	5-4-2
W-7-1	5-5-2
W-8-1	5-6-1
W-10-3	5-8-4
W-14-1	5-9
W-15-2	5-10
W-16	
W-17	
W-20-1	
W-22	
 - 3) SANITARY SEWER AND SERVICES, WATER SERVICES, PAVEMENT AND CURB AND GUTTER ARE NOT A PART OF THIS CONTRACT AND ARE SHOWN FOR INFORMATION ONLY.
 - 4) 6" WATER LINE NOT IN THIS CONTRACT SEE CITY PROJ 2114.

AS BUILT INFORMATION			BENCH MARKS			SURVEY INFORMATION			ENGINEER'S SEAL		
CONTRACT NO.	NEW CONSTRUCTION	DATE	ACCS BENCH MARK 1-122 LOCATED 1.0 MILES NORTH OF THE INTERSECTION OF TRAMWAY BLVD AND MONTGOMERY BLVD NE AND 1351 MIDWAY BETWEEN THE WESTERLMOST OF TWO ELECTRIC POWER LINE PULVINS. A STANDARD BRASS TABLET, STAMPED "1-122", SET IN THE TOP OF A CONCRETE POST, 0.2' ABOVE GROUND. ELEVATION = 5986.408 FEET (MSLD).	NO.	DATE	NO.	DATE	NO.	DATE	NO.	DATE
REVISIONS			REVISIONS			REVISIONS			REVISIONS		
NO.	DATE	REMARKS	NO.	DATE	REMARKS	NO.	DATE	REMARKS	NO.	DATE	REMARKS
DESIGNED BY TKW			DESIGNED BY TKW			DESIGNED BY TKW			DESIGNED BY TKW		
DRAWN BY TKW			DRAWN BY TKW			DRAWN BY TKW			DRAWN BY TKW		
CHECKED BY DAL			CHECKED BY DAL			CHECKED BY DAL			CHECKED BY DAL		
DATE 2-11-85			DATE 2-11-85			DATE 2-11-85			DATE 2-11-85		

ESPEY, HUSTON & ASSOC., INC.
 Engineering & Environmental Consultants
 4801 INDIAN SCHOOL ROAD NE SUITE 204
 ALBUQUERQUE, NEW MEXICO 87110
 PHONE (505) 255-1625

CITY OF ALBUQUERQUE
 MUNICIPAL DEVELOPMENT DEPARTMENT
 ENGINEERING DIVISION

TITLE:
 ROYAL OAK UNIT 1
 LOWER ZONE 9E-14" WATER LINE
 ROYAL OAK AVE NE @ STA 7+50.00 TO @ STA 13+53.32

APPROVALS	ENGINEER	DATE	APPROVALS	ENGINEER	DATE
City Engineer	<i>[Signature]</i>	8/7/85	Liquid Waste	<i>[Signature]</i>	8/7/85
A.C.E.-Design	<i>[Signature]</i>	9/10/85	Traffic	<i>[Signature]</i>	4/17/86
A.E.E.-Hydrology	<i>[Signature]</i>	4/17/85	Water	<i>[Signature]</i>	8/7/85

DRAWING NO. 2412 **MAP NO.** E-22 **SHEET** 6 **OF** 7

GENERAL NOTES FOR TRAFFIC CONTROL

- ALL TRAFFIC CONTROL DEVICES SHALL COMPLY WITH CHAPTER VI OF THE 1978 EDITION OF THE "MANUAL FOR UNIFORM TRAFFIC CONTROL DEVICES".
- THE CONTRACTOR SHALL PREPARE AND SUBMIT TO THE PROJECT ENGINEER A DETAILED CONSTRUCTION SCHEDULE WHICH IS SUBJECT TO THE APPROVAL OF THE CITY TRAFFIC ENGINEER, 3 WORKING DAYS PRIOR TO COMMENCING CONSTRUCTION.
- UNLESS OTHERWISE PROVIDED AS PART OF THE CONSTRUCTION DOCUMENTS, THE CONTRACTOR SHALL PREPARE AND SUBMIT TO THE PROJECT ENGINEER A DETAILED TRAFFIC CONTROL PLAN, WHICH IS SUBJECT TO THE APPROVAL OF THE CITY TRAFFIC ENGINEER, 3 WORKING DAYS IN ADVANCE OF ANY CLOSURES.
- CONTRACTOR SHALL NOTIFY THE FOLLOWING SERVICES 24 HOURS IN ADVANCE OF ANY COMPLETE CLOSURES: POLICE DEPARTMENT, FIRE DEPARTMENT, AMBULANCE SERVICES, AND THE TRANSIT DEPARTMENT.
- PERMITS TO BARRICADE OR DETOUR TRAFFIC MUST BE OBTAINED FOR EACH PHASE OF CONSTRUCTION THROUGH THE TRAFFIC ENGINEERS OFFICE AT LEAST 24 HOURS IN ADVANCE OF CONSTRUCTION ACTIVITIES.
- ALL ADVANCE WARNING SIGNS AND BARRICADES MUST BE INSTALLED BEFORE CONSTRUCTION BEGINS AS DIRECTED BY THE ENGINEER.
- ALL SIGN LOCATIONS WILL BE SELECTED IN THE FIELD AND APPROVED BY THE PROJECT ENGINEER.
- ALL ADVANCE WARNING SIGNS SHALL BE 48"x48" MINIMUM.
- ALL ADVANCE WARNING SIGNS NOT DIRECTLY APPLICABLE SHALL BE REMOVED, COMPLETELY COVERED OR TURNED AWAY FROM ONCOMING TRAFFIC.
- ALL CONSTRUCTION SIGNING SHALL BE BLACK ON A REFLECTORIZED ORANGE FIELD UNLESS OTHERWISE SPECIFIED. ALL CONSTRUCTION BARRICADES AND CHANNELIZATION DEVICES SHALL BE ORANGE ON WHITE, REFLECTORIZED, UNLESS OTHERWISE SPECIFIED.
- ALL SIGNS WILL BE GROUND MOUNTED ON SINGLE OR DOUBLE POSTS WITH THE BOTTOM OF THE SIGN 7 FEET ABOVE SIDEWALK LEVEL. EXISTING POSTS MAY BE USED AT SOME LOCATIONS, WITH THE APPROVAL OF THE PROJECT ENGINEER. PORTABLE SIGN SUPPORTS WILL BE ACCEPTABLE AS AN ALTERNATIVE FOR SIGNS WHICH ARE IN PLACE FOR LESS THAN 1 WEEK. SIGNS MAY NOT BE MOUNTED ON BARRELS OR BARRICADES.
- ALL EXISTING REGULATORY SIGNS THAT NEED TO BE REMOVED, RELOCATED OR REINSTALLED SHALL BE DONE BY THE CITY OF ALBUQUERQUE, TRAFFIC ENGINEERING DIVISION. THE CONTRACTOR SHALL NOTIFY THE TRAFFIC ENGINEERING DIVISION 3 WORKING DAYS IN ADVANCE OF ANY REQUIRED WORK.
- TRAFFIC CONTROL DEVICES REQUIRED AFTER DARK ARE TO BE EQUIPPED WITH WARNING LIGHTS. TYPE (A) FLASHING WARNING LIGHTS SHALL BE USED ON ALL ADVANCE WARNING SIGNS AND ON ALL DEVICES WHICH ARE INTENDED TO WARN MOTORIST OR PEDESTRIANS OF HAZARDS OR OBSTRUCTIONS IN OR NEAR THE TRAVEL PATH. TYPE (C) STEADY BURN LIGHTS SHALL BE USED ON ALL DEVICES WHICH ARE INTENDED TO DEFINE THE TRAVEL PATH.
- ALL SIGNS, BARRICADES AND/OR BARRELS WILL BE REFLECTORIZED. ALL BARRELS MAY HAVE SAND BALLAST LIMITED TO 100 LBS.
- ALL SIGNS, BARRICADES AND/OR BARRELS WILL BE MOVED FORWARD AS THE CONSTRUCTION PROGRESSES (WHERE APPLICABLE).
- CONTRACTOR SHALL INSPECT AND MAINTAIN ALL BARRICADES AT LEAST ONCE EACH DAY EXCEPT FOR BARRICADES ON OR ADJACENT TO ARTERIAL AND COLLECTOR STREETS, WHICH SHALL BE CHECKED TWICE DAILY, INCLUDING INSPECTION DURING HOURS OF DARKNESS.
- BARRELS AND BARRICADES ARE NOT TO BE INTERMIXED IN THE SAME SERIES OF CHANNELIZATION.
- EXCAVATIONS MUST BE PATCHED OR PATCHED, PRIOR TO OPENING TO TRAFFIC.
- A MINIMUM WIDTH OF 11 FEET SHALL BE PROVIDED FOR TRAFFIC IN ONE DIRECTION.
- EQUIPMENT AND MATERIALS ARE NOT TO BE STORED WITHIN THE STREET RIGHT-OF-WAY DURING NON-WORKING HOURS.
- THE CONTRACTOR SHALL MAINTAIN ACCESS TO BUSINESS AND RESIDENCES ADJACENT TO THE CONSTRUCTION AREA.
- THE CONTRACTOR SHALL PROVIDE AND MAINTAIN A SAFE AND ADEQUATE MEANS OF CHANNELIZING PEDESTRIAN TRAFFIC AROUND ALL WORK AREAS THROUGHOUT THE PERIOD OF CONSTRUCTION. ALL SUCH CHANNELIZATION SHALL BE ARRANGED TO PREVENT PEDESTRIANS FROM HAVING TO ENTER THE ROADWAY IN ORDER TO PASS AROUND WORK AREAS.
- THE CONTRACTOR SHALL BE REQUIRED TO KEEP THE PUBLIC INFORMED, THROUGH THE LOCAL NEWS MEDIA OF CONSTRUCTION OPERATIONS INVOLVING STREET OR LANE CLOSURES, AND SHALL PROVIDE THE CITY TRAFFIC ENGINEER DOCUMENTED PROOF THAT THIS HAS BEEN DONE.
- CONSTRUCTION LIMITS SHALL BE SET AT 200 FEET.
- CONSTRUCTION ACTIVITIES SHALL NOT AFFECT THRU LANES OF TRAFFIC ON TRAMWAY OR SPAIN FROM 4 P.M. TO 9 A.M.
- CONTRACTOR SHALL CROSS TRAMWAY WITH THE WATER LINE ONE LANE AT A TIME USING A FLAGMAN OPERATION - 9 A.M. TO 4 P.M. ONLY.
- WHEN CONSTRUCTION ACTIVITIES ARE TAKING PLACE ON THE SHOULDER AREA OF TRAMWAY, CONTRACTOR SHALL ERECT ADVANCE SIGNING CONSISTING OF W20-1 (ROAD CONSTRUCTION AHEAD) AND W21-5 (SHOULDER WORK) AT 400 AND 800 FROM THE CONSTRUCTION RESPECTIVELY AND HAVE BARRICADES RUN THE CIRCUMFERENCE OF THE EXCAVATION.

KEY:

- BARRICADE - TYPE I, TYPE II, OR A BARREL
- BARRICADE - TYPE III
- ▬ VERTICAL PANEL
- ▬ WARNING SIGN
- L DISTANCE BETWEEN SIGNS - A DISTANCE MEASURED IN FEET EQUAL TO A VALUE OF TEN TIMES THE SPEED LIMIT OF THE STREET.

TAPER LENGTH - SEE CHART

TANGENT LENGTH - TANGENT LENGTH IS EQUAL TO THE TAPER LENGTH FOR A GIVEN STREET

FLAG MAN POSITION

SPACING BETWEEN BARRICADES - A DISTANCE MEASURED IN FEET EQUAL TO A VALUE OF THE SPEED LIMIT.

TAPER REQUIREMENTS

SPEED LIMIT (MPH)	TAPER LENGTH (FEET)			MAXIMUM DISTANCE BETWEEN DEVICES (FEET)	MINIMUM NUMBER OF DEVICES REQUIRED
	10' LANE	11' LANE	12' LANE		
25	104	115	125	25	6
30	150	165	185	30	7
35	204	225	245	35	8
40	267	293	320	40	9
45	450	495	540	45	13
50	500	550	600	50	13
55	550	605	660	55	13

W20-1
-A-

W20-SR
-B-

W20-SL
-D-

W20-S
-L-

W20-5
-F-

W20-4
-G-

W20-3
-N-

W20-3
-P-

R4-7a
-Q-

M4-9
-S-

M4-10
-T-

R11-2
-U-

R11-4
-V-

W21-5
-W-

-X-

By: Brian Delan
Date: 5/1/86

20 24120706

CITY OF ALBUQUERQUE WATER RESOURCES DEPARTMENT ENGINEERING DIVISION				
TITLE: LOWER ZONE 9E - 14" WATERLINE, TRAFFIC CONTROL PLAN				
APPROVALS	ENGINEER	DATE	APPROVALS	ENGINEER
City Engineer	<i>[Signature]</i>	5/1/86	Liquid Waste	<i>[Signature]</i>
A.C.E. - Design	<i>[Signature]</i>	5/1/86	Traffic	<i>[Signature]</i>
A.C.E. - Hydrology	<i>[Signature]</i>	5/1/86	Water	<i>[Signature]</i>
DRAWING NO.	2412	MAP NO.	E-22,F-22,23	SHEET 7 OF 7