

EASTRIDGE UNIT 4

BLOCK 11


1" = 20'

TRACT A-3-1-A


TRACT A-3-1-B-1

TRACT B-2-A


SITE PLAN SHOWN FOR CLARITY

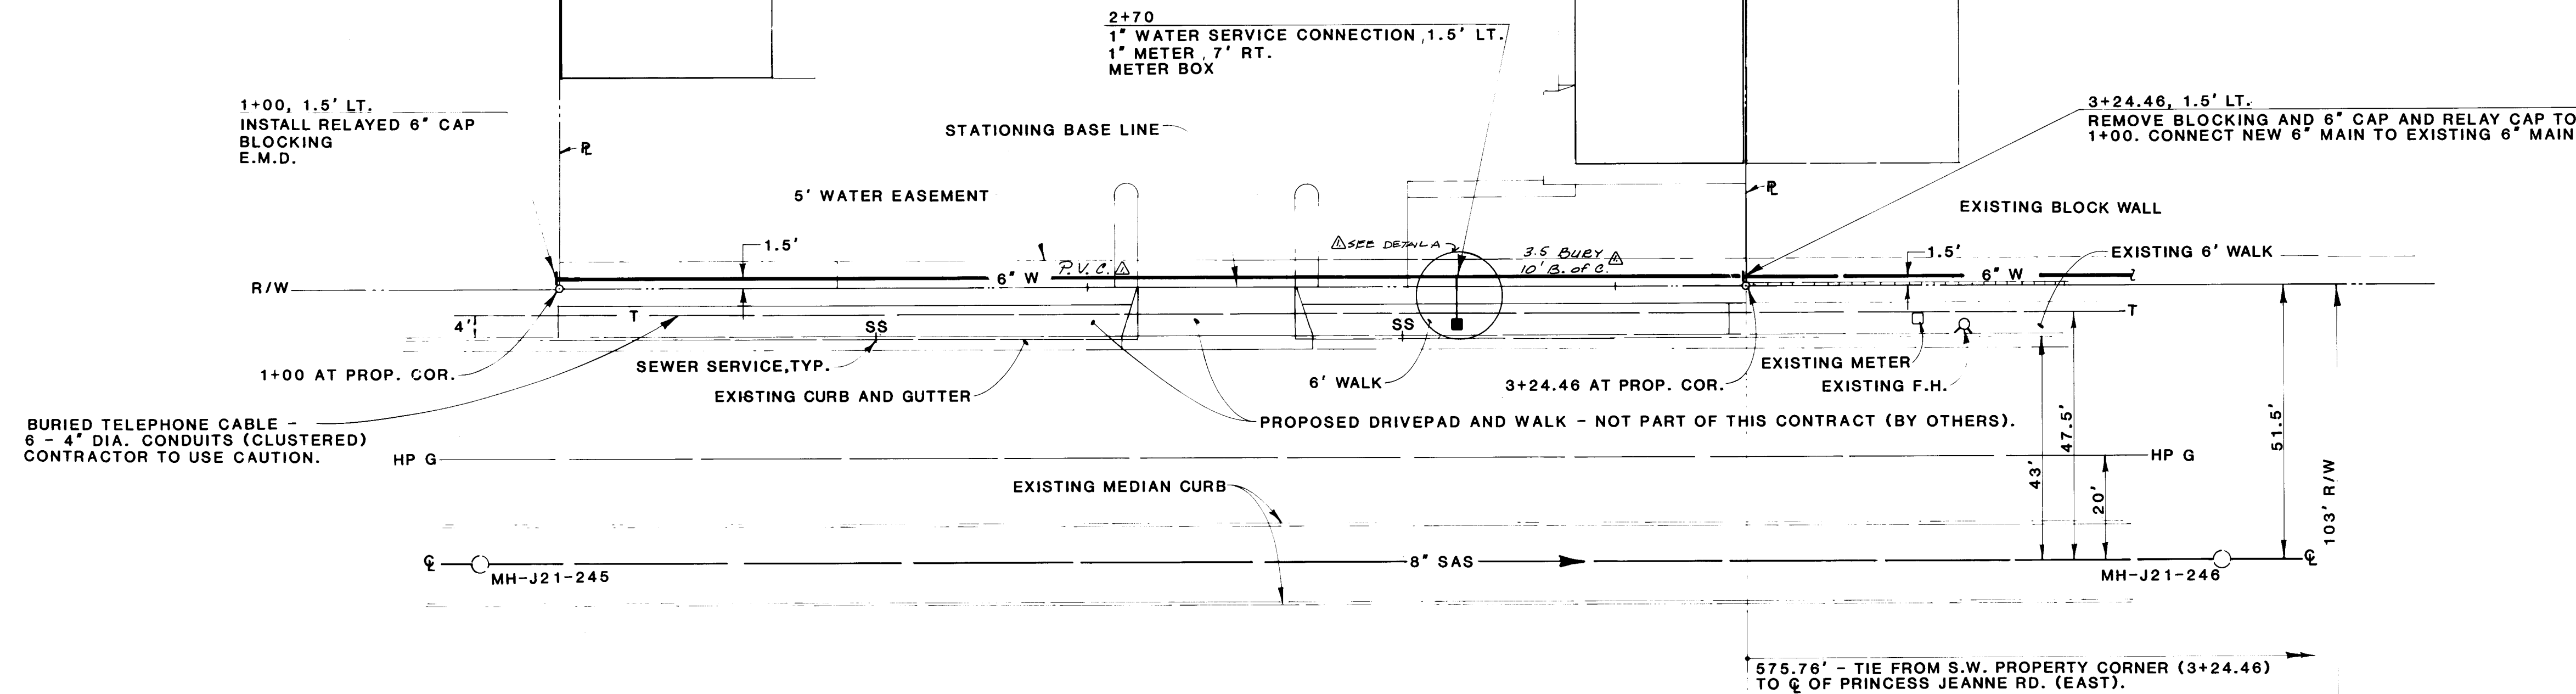


JUAN TABO BLVD. N.E.

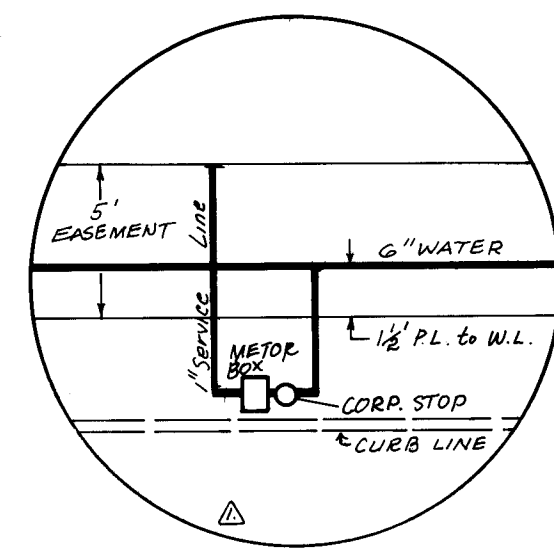

DETAIL A

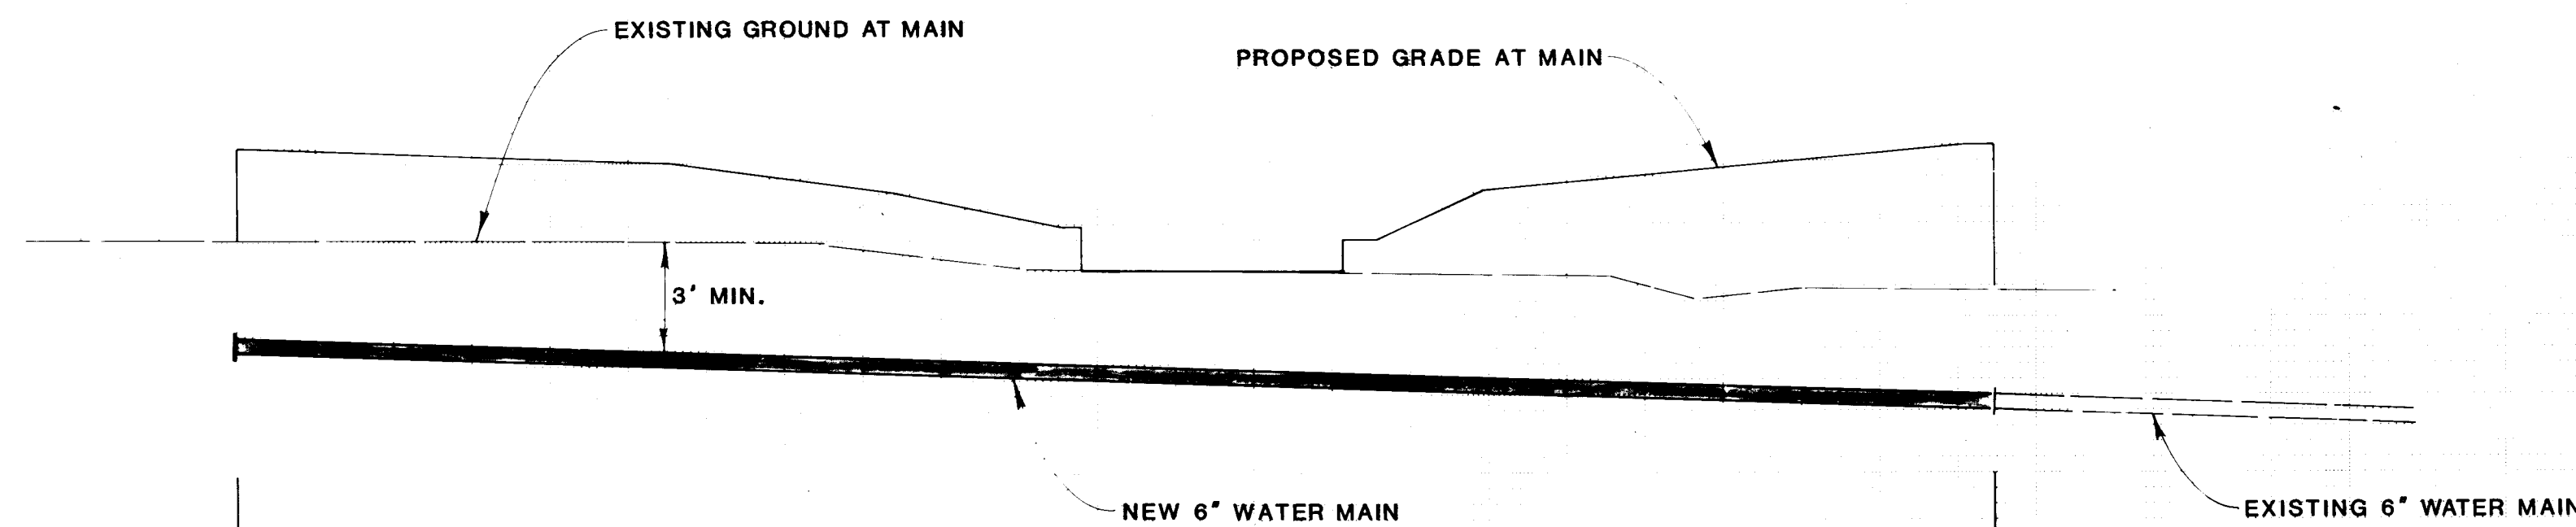

APPROVED FOR CONSTRUCTION
CITY ENGINEER
DATE 6/27/85

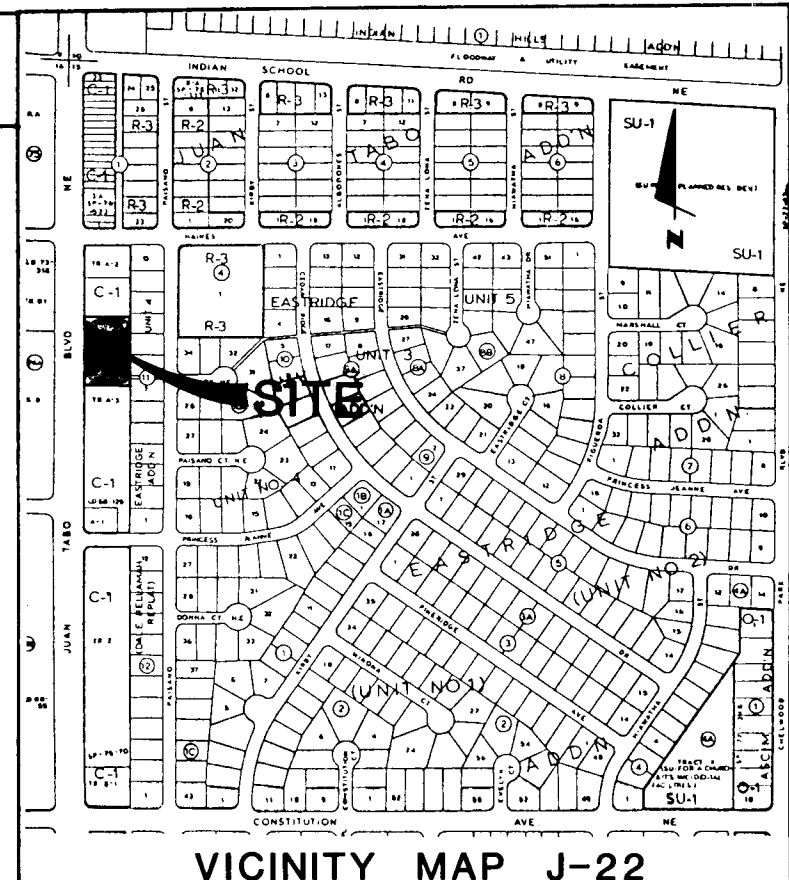

NOTICE TO CONTRACTORS

- 1) All work detailed on these plans to be performed under contract shall, except as otherwise stated or provided for herein, be constructed in accordance with the New Mexico Standard Specifications for Public Works Construction - 1979 Edition (referred to herein as the Standard Specifications) and the Contract Documents for Public Works Contract 85-1.
- 2) Two (2) working days prior to any excavation, contractor must contact Line Locating Service, 765-1234, for location of existing utilities.
- 3) Prior to construction, the contractor shall excavate and verify the horizontal and vertical locations of all obstructions. Should a conflict exist, the contractor shall notify the engineer or surveyor so that the conflict can be resolved with minimum amount of delay.

THE FOLLOWING NOTES APPLY WHEN CHECKED:

- ☒ All utilities and utility service lines shall be installed prior to paving. (SITE WORK)
- ☒ Backfill compaction shall be according to specified street use. (RESIDENTIAL)
- ☐ Tack coat requirements shall be determined by the City Engineer.
- ☐ Sidewalks and wheelchair ramps within the curb returns shall be constructed wherever a new curb return is constructed.
- ☐ If curb is depressed for a driveway or a handicap ramp, the driveway or ramp shall be constructed prior to acceptance of the curb and gutter.
- ☐ All storm drainage facilities shall be completed prior to final acceptance.

NOTES

- INSTALL E.M.D. AT ALL BENDS, CAPS AND TEES.
- APPROVED PIPE MATERIAL:
SEWER- PVC, VCP, DI OR APPROVED EQUAL
WATER- C900, PVC, AC, DI OR APPROVED EQUAL.
- SEE PROJECT 2342 FOR EXISTING WATER MAIN INFORMATION IN TRACT B-2-A.

APPROVAL OF AS BUILT DRAWINGS
ASST. CITY ENGINEER - FIELD
W. J. McNamara
DATE 10-10-85


WH
WEISS / HINES ENGINEERING, INC.
1100-B ALVARADO N.E.
ALBUQUERQUE, NEW MEXICO, 87110
(505) 266-3444

CITY OF ALBUQUERQUE
MUNICIPAL DEVELOPMENT DEPARTMENT
ENGINEERING DIVISION

TITLE: WATER LINE EXTENSION
ALONG JUAN TABO BLVD. BETWEEN PRINCESS JEANNE AND HAINES N.E.

APPROVALS	ENGINEER	DATE	APPROVALS	ENGINEER	DATE
City Engineer	W. J. McNamara	6/27/85	Liquid Waste	R. J. Hines	6/24/85
A.C.E. - Design	A. C. E.	7/8/85	Traffic	N. A. H.	6/5/85
Hydrology	M. A. G. A.	6/6/85	Water	R. J. Hines	6/4/85

DRAWING NO.	MAP NO.	SHEET	OF
2471	J-22	1	1

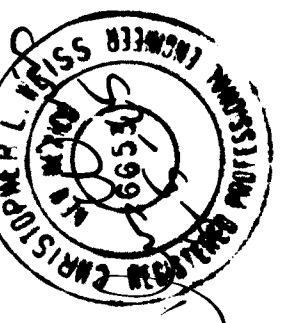

NO.	DATE	REVISIONS	DESIGN
1	4-85	DATE 4-85	DATE 4-85
2	4-85	DATE 4-85	DATE 4-85
3	4-85	DATE 4-85	DATE 4-85