

SOMBRA DEL OSO APARTMENTS


TAYLOR RANCH, TRACT 27 B-A
IN
ALBUQUERQUE, NEW MEXICO

FOR

THE BAER COMPANY

DEVELOPMENT IMPROVEMENT PLANS


UTILITY IMPROVEMENTS

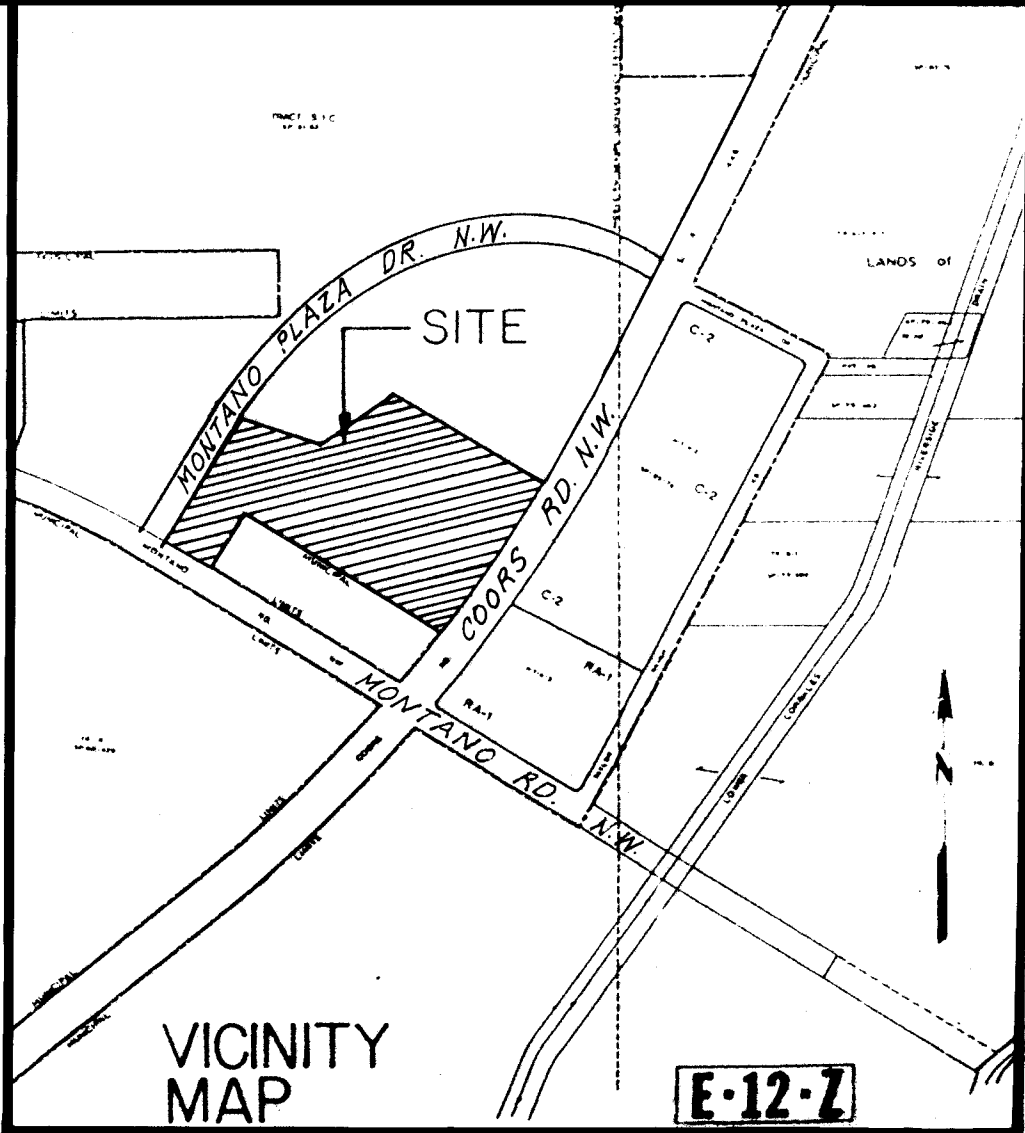

GENERAL NOTES:

1. ALL WORK DETAILED ON THESE PLANS TO BE PERFORMED UNDER CONTRACT SHALL, EXCEPT AS OTHERWISE STATED OR PROVIDED FOR HEREON, BE CONSTRUCTED IN ACCORDANCE WITH THE CITY OF ALBUQUERQUE INTERIM STANDARD SPECIFICATIONS PUBLIC WORKS CONSTRUCTION, 1985.
2. TWO (2) WORKING DAYS PRIOR TO ANY EXCAVATION, CONTRACTOR MUST CONTACT LINE LOCATING SERVICE, 765-1234, FOR LOCATION OF EXISTING UTILITIES.
3. PRIOR TO CONSTRUCTION, THE CONTRACTOR SHALL EXCAVATE AND VERIFY THE HORIZONTAL AND VERTICAL LOCATIONS OF ALL OBSTRUCTIONS. SHOULD A CONFLICT EXIST, THE CONTRACTOR SHALL NOTIFY THE ENGINEER OR SURVEYOR SO THAT THE CONFLICT CAN BE RESOLVED WITH MINIMUM AMOUNT OF DELAY.
4. ALL UTILITIES AND UTILITY SERVICE LINES SHALL BE INSTALLED PRIOR TO PAVING.
5. BACKFILL COMPACTION SHALL BE ACCORDING TO SPECIFIED STREET USE.
6. SIDEWALKS AND WHEELCHAIR RAMPS WITHIN THE CURB RETURNS SHALL BE CONSTRUCTED WHEREVER A NEW CURB RETURN IS CONSTRUCTED.
7. IF CURB IS DEEPENED FOR A DRIVEPAD OR A HANDICAP RAMP THE DRIVEPAD OR RAMP SHALL BE CONSTRUCTED PRIOR TO ACCEPTANCE OF THE CURB AND GUTTER.
8. RETENTION POND IMPROVEMENTS WITHIN THE DRAINAGE EASEMENT SHALL BE SUBMITTED UNDER SEPARATE PROJECT FOR DRC APPROVAL. (City Prot. No. 2759) AND

SHEET NO.	DESCRIPTION
1	TITLE SHEET
2-3	PLATS OF GEOMETRY
4	GRADING PLAN VOID
5	GRADING PLAN- FINISHED CONTOURS
6	UTILITY COMPOSITE
7-14	UTILITIES-PLAN AND PROFILE
15	PAVING COMPOSITE

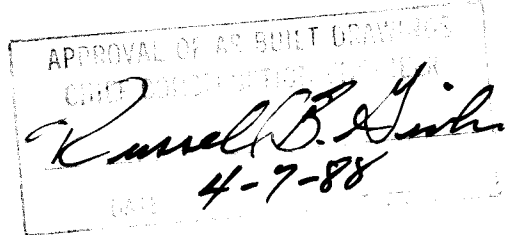


26 27450188


SET NO.
DATE

REV.	SHEETS	CITY ENGR.	DATE	USER	DEPT.	DATE	USER	DEPT.	DATE
APPROVAL OF REVISIONS									

	GARDNER, MASON & ASSOC., INC. ALBUQUERQUE, NEW MEXICO	APPROVED FOR CONSTRUCTION <i>[Signature]</i> CITY ENGINEER DATE 5/14/86
	SHEET 1 OF 15	

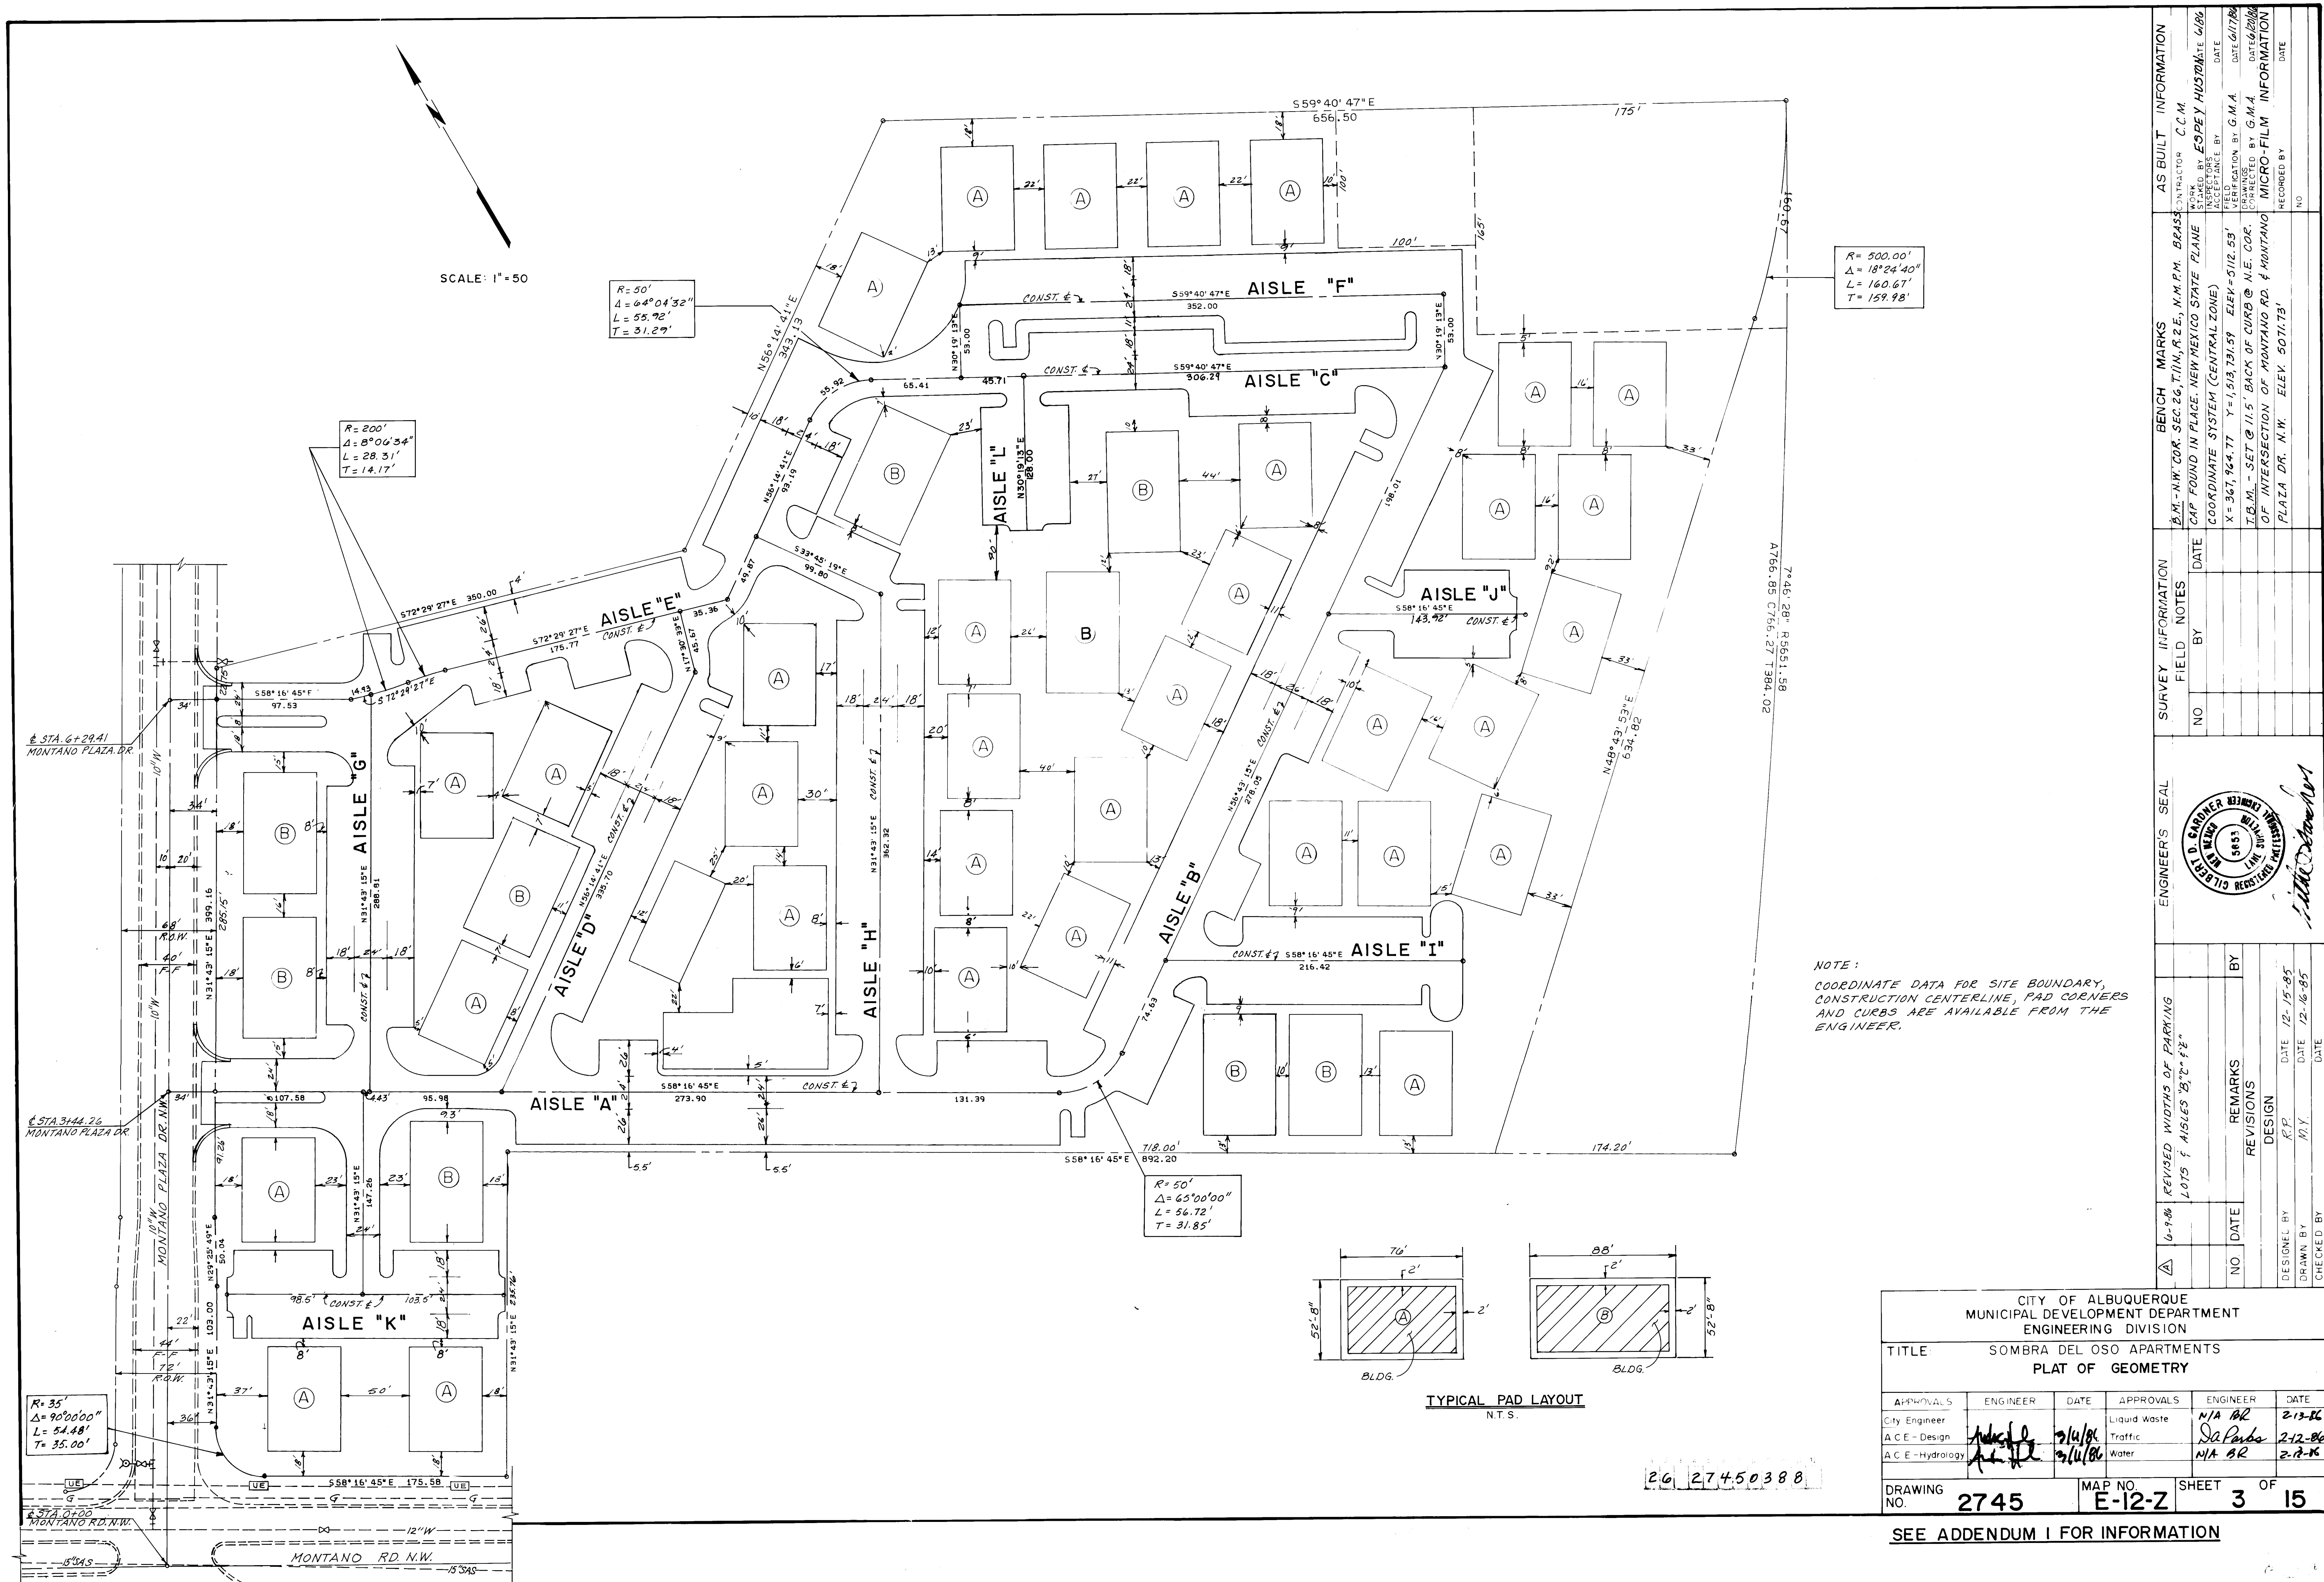

NOTE:
COORDINATE DATA FOR SITE BOUNDARY,
CONSTRUCTION CENTERLINE, PAD CORNERS
AND CURBS ARE AVAILABLE FROM THE
ENGINEER.

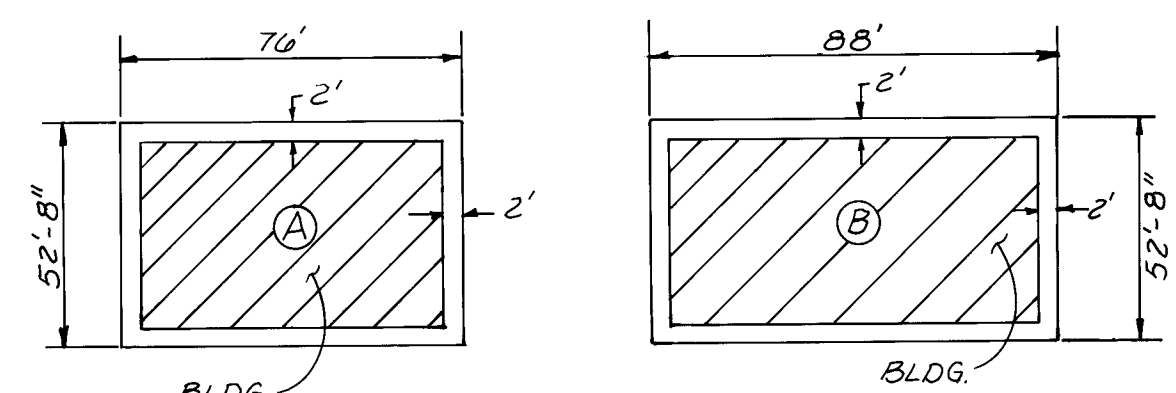


TYPICAL PAD LAYOUT
N.T.S.

26 27450388






CITY OF ALBUQUERQUE MUNICIPAL DEVELOPMENT DEPARTMENT ENGINEERING DIVISION					
TITLE SOMBRA DEL OSO APARTMENTS PLAT OF GEOMETRY					
APPROVALS	ENGINEER	DATE	APPROVALS	ENGINEER	DATE
City Engineer			Liquid Waste	N/A GR	2-12-86
A.C.E. - Design		2/14/86	Traffic	SA Pando	2-12-86
A.C.E. - Hydrology		2/14/86	Water	N/A GR	2-12-86
DRAWING NO. 2745		MAP NO. E-12-Z		SHEET 3 OF 15	

SEE ADDENDUM I FOR INFORMATION


A		6-9-86		REVISED WIDTHS OF PARKING LOTS & AISLES "B", "C" & "E"		ENGINEER'S SEAL		SURVEY INFORMATION			BENCH MARKS		AS BUILT INFORMATION			
								FIELD NOTES			CAP FOUND IN PLACE, NEW MEXICO STATE PLANE COORDINATE SYSTEM (CENTRAL ZONE)		CONTRACTOR C.C.M.			
								NO			BY		DATE			
				REMARKS							X = 367,964.77 Y = 1,513,731.59 ELEV = 5112.53'		FIELD VERIFICATION BY G.M.A.		DATE 6/17/86	
				DESIGN							T.B.M. - SET @ 11.5' BACK OF CURB @ N.E. COR. OF INTERSECTION OF MONTANO RD. & MONTANO PLAZA DR. N.W. ELEV. 5071.73'		CORRECTED BY G.M.A.		DATE 6/17/86	
		DESIGNED BY R.P.		DATE 12-15-85									RECORDED BY		DATE	
		DRAWN BY M.Y.		DATE 12-16-85											NO	
		CHECKED BY		DATE												

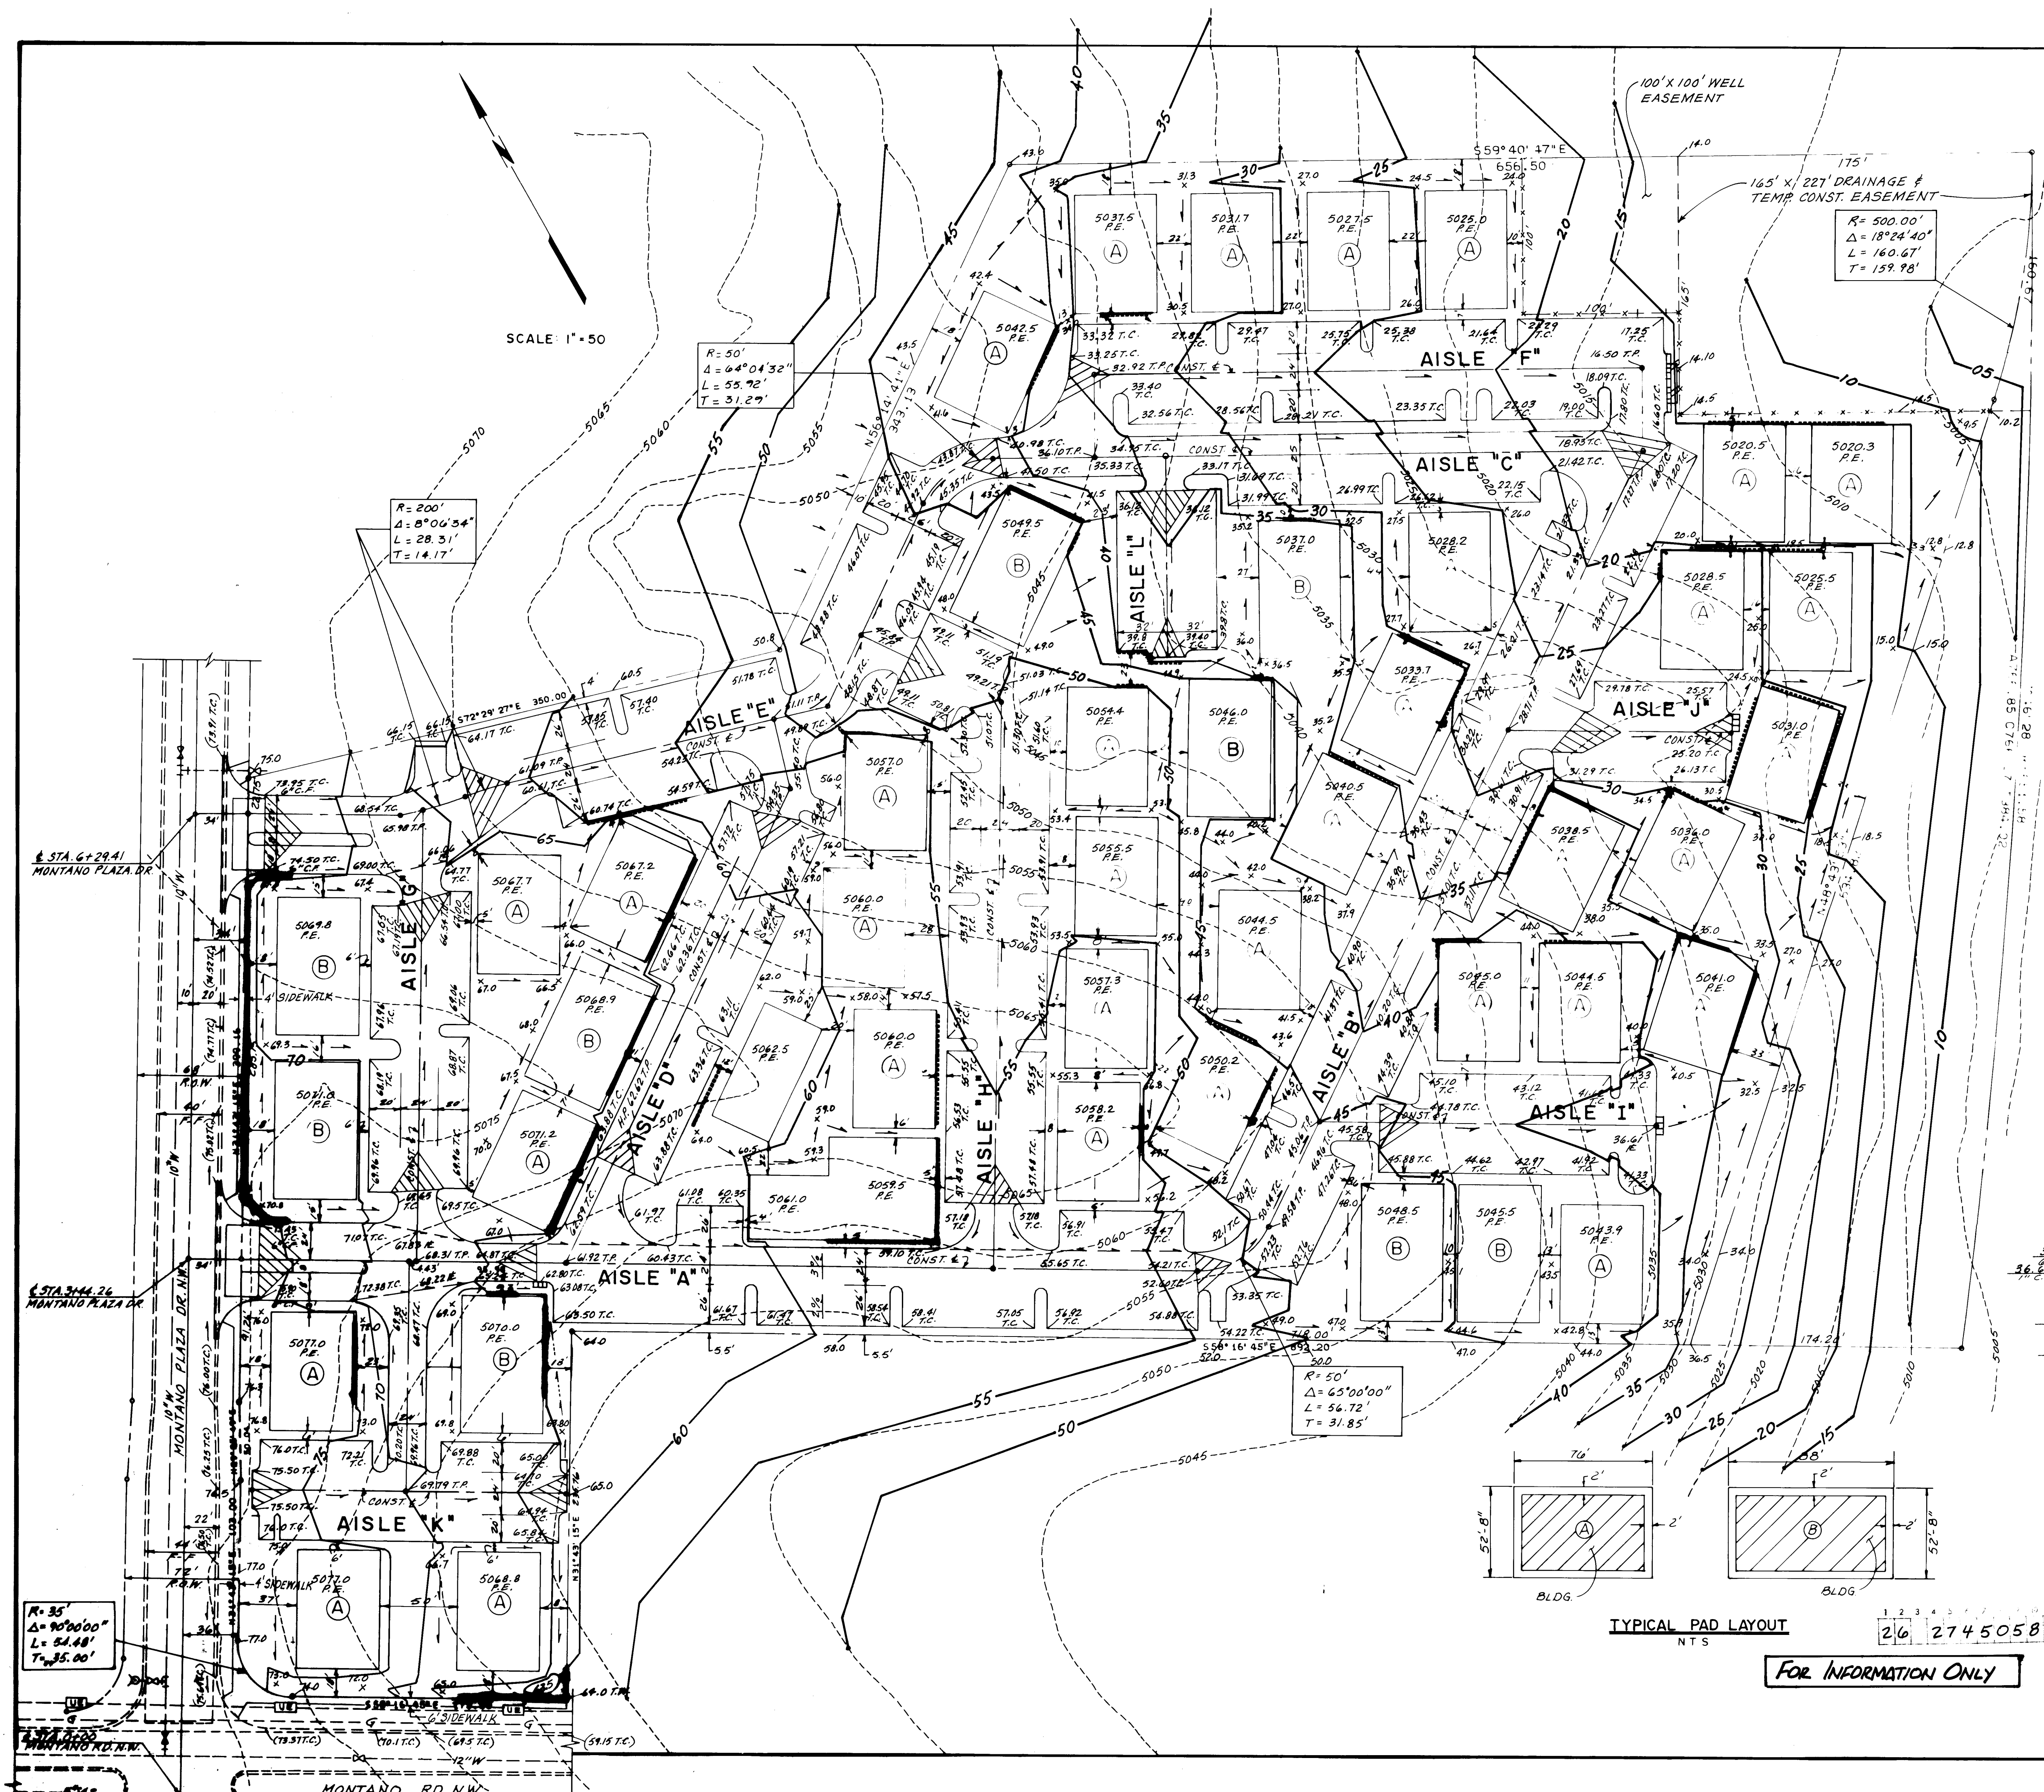

 - LEGEND**
- Pavement Crown Transition
 - EXIST. CONTOUR
 - FINISHED CONTOUR
 - PAD ELEVATION
 - Flow Line
 - High Point
 - Top of Curb
 - Flow Line
 - Curb Face
 - Exist. Contour
 - Exist. Elevation
 - Finished Elevation
 -
 - New Concrete
 - Top of Pavement
 - BOTTOM OF WALL
 - TOP OF WALL

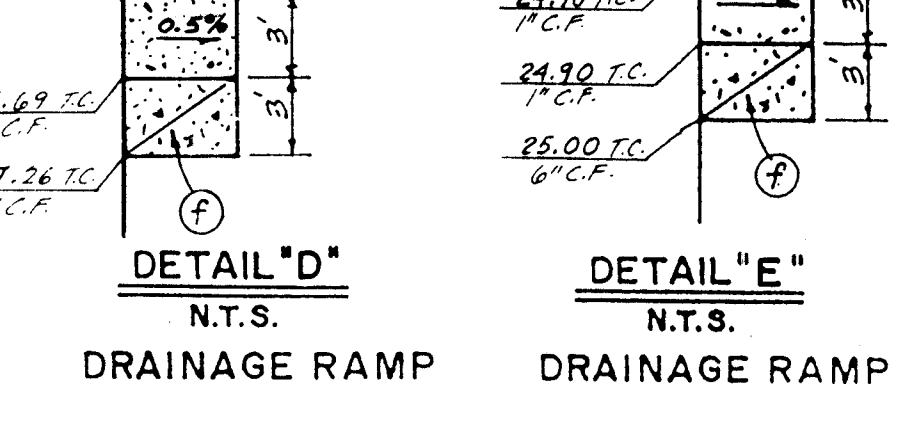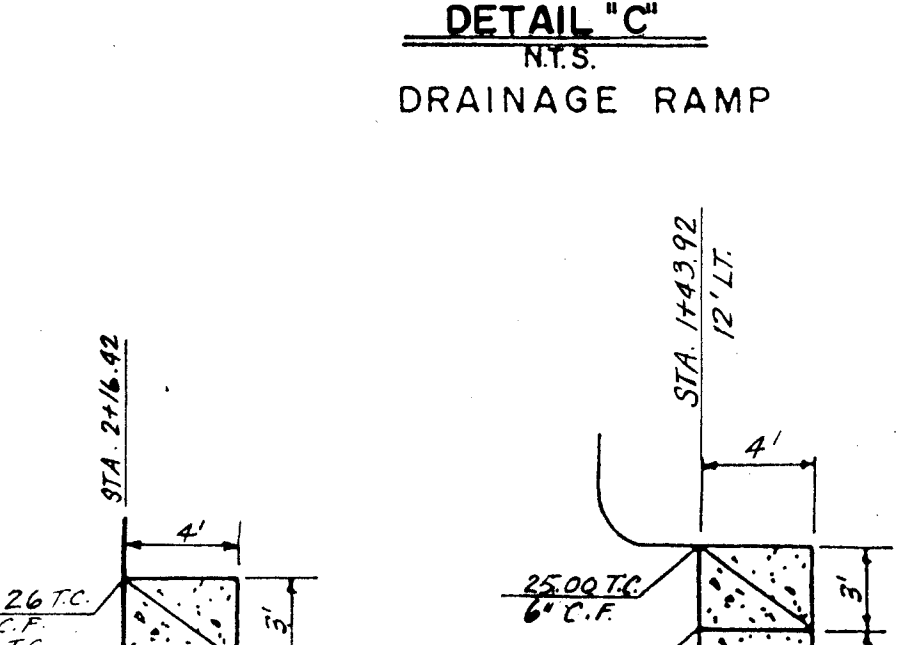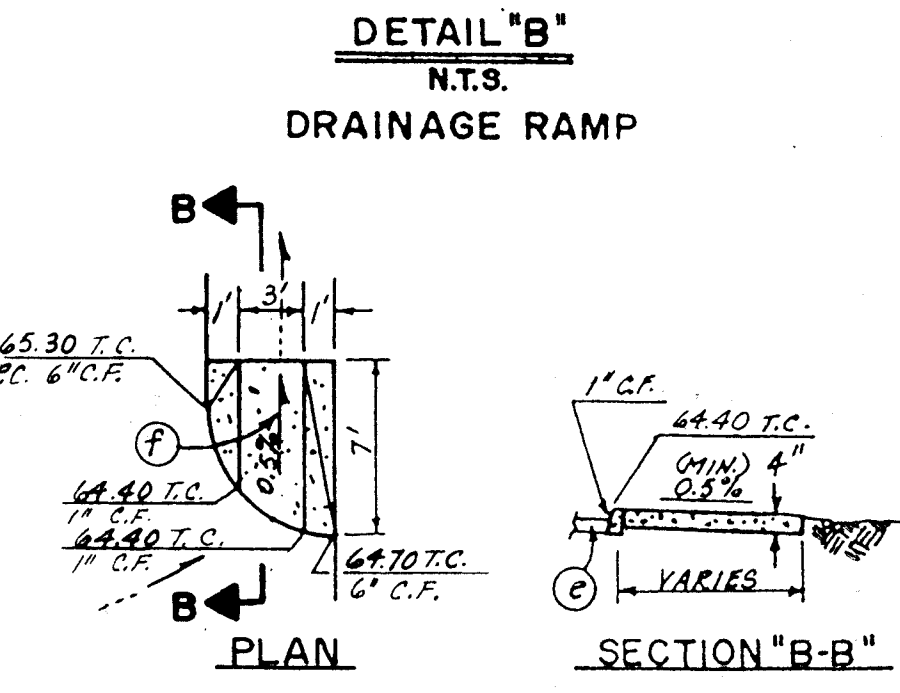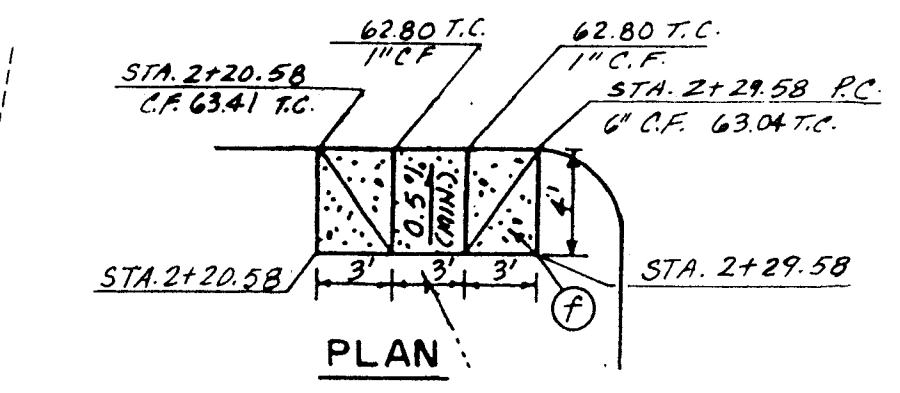


NOTE: REFER TO SHEET 4 FOR CONSTRUCTION NOTES.

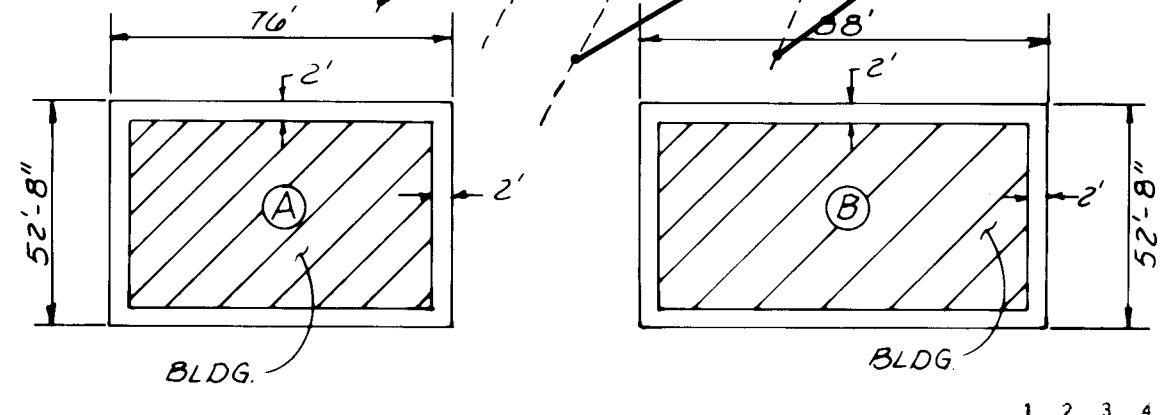

FOR INFORMATION ONLY

ENGINEER'S SEAL										SURVEY INFORMATION				BENCH MARKS				AS BUILT INFORMATION															
SEAL REGISTERED PROFESSIONAL ENGINEER STATE OF NEW MEXICO 58933 KARL E. SANDERSON REVISED 06/06 <i>Karl E. Sanderson</i>										FIELD NOTES				DATE				BY				DATE				DATE				DATE			
REVISIONS										BY				DATE				DATE				DATE				DATE							
DESIGN										DATE				DATE				DATE				DATE				DATE							
DESIGNED BY										DATE				DATE				DATE				DATE				DATE							
DRAWN BY										DATE				DATE				DATE				DATE				DATE							
CHECKED BY										DATE				DATE				DATE				DATE				DATE							
DEPARTMENT										DATE				DATE				DATE				DATE				DATE							
VISION										DATE				DATE				DATE				DATE				DATE							
DEPARTMENTS										DATE				DATE				DATE				DATE				DATE							
THED CONTOURS										DATE				DATE				DATE				DATE				DATE							
ROVALS										DATE				DATE				DATE				DATE				DATE							
Waste										DATE				DATE				DATE				DATE				DATE							
N/A BR										DATE				DATE				DATE				DATE				DATE							
N/A BR										DATE				DATE				DATE				DATE				DATE							
SHEET										DATE				DATE				DATE				DATE				DATE							
5										DATE				DATE				DATE				DATE				DATE							
15										DATE				DATE				DATE				DATE				DATE							

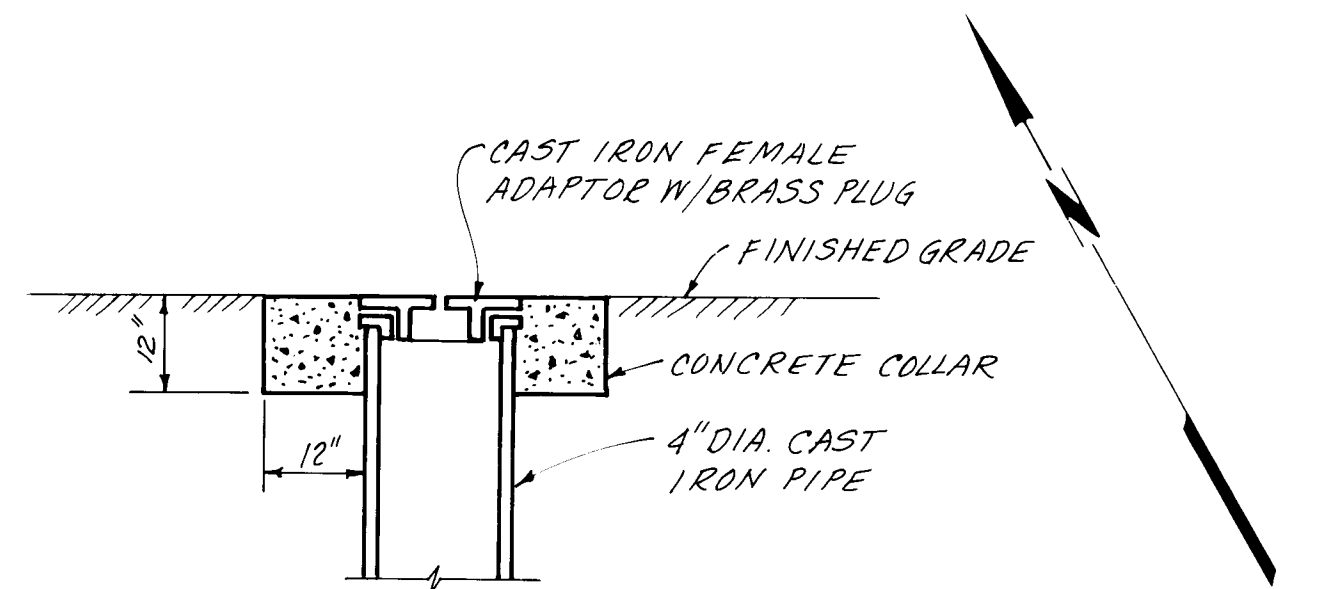

CLEANOUT DETAIL
TYPICAL
N.T.S.

SCALE: 1"=50'

2-8" 90° BENDS W/ CONC.
THRUST BLOCK

3-8" 22 1/2° BENDS W/ CONC.
THRUST BLOCK

1-8" X 8" X 8" Y BRANCH
W/ CONC. THRUST BLOCK

1-8" X 8" X 8" TEE
1-8" 11/4° BEND W/
CONC. THRUST BLOCK

2-8" 90° BENDS
W/ CONC. THRUST
BLOCK

6 STA. 6+29.41
MONTANO PLAZA DR.

6 STA. 3+44.26
MONTANO PLAZA DR.

6 STA. 0+00
MONTANO RD. N.W.

6 STA. 3+44.26
MONTANO PLAZA DR.

6 STA. 0+00
MONTANO RD. N.W.

6 STA. 0+00
MONTANO RD. N.W.

6 STA. 3+44.26
MONTANO PLAZA DR.

6 STA. 0+00
MONTANO RD. N.W.

6 STA. 0+00
MONTANO RD. N.W.

6 STA. 3+44.26
MONTANO PLAZA DR.

6 STA. 0+00
MONTANO RD. N.W.

6 STA. 0+00
MONTANO RD. N.W.

6 STA. 3+44.26
MONTANO PLAZA DR.

6 STA. 0+00
MONTANO RD. N.W.

6 STA. 0+00
MONTANO RD. N.W.

6 STA. 3+44.26
MONTANO PLAZA DR.

6 STA. 0+00
MONTANO RD. N.W.

6 STA. 0+00
MONTANO RD. N.W.

6 STA. 3+44.26
MONTANO PLAZA DR.

6 STA. 0+00
MONTANO RD. N.W.

6 STA. 0+00
MONTANO RD. N.W.

6 STA. 3+44.26
MONTANO PLAZA DR.

6 STA. 0+00
MONTANO RD. N.W.

6 STA. 0+00
MONTANO RD. N.W.

6 STA. 3+44.26
MONTANO PLAZA DR.

6 STA. 0+00
MONTANO RD. N.W.

6 STA. 0+00
MONTANO RD. N.W.

6 STA. 3+44.26
MONTANO PLAZA DR.

6 STA. 0+00
MONTANO RD. N.W.

6 STA. 0+00
MONTANO RD. N.W.

6 STA. 3+44.26
MONTANO PLAZA DR.

6 STA. 0+00
MONTANO RD. N.W.

6 STA. 0+00
MONTANO RD. N.W.

6 STA. 3+44.26
MONTANO PLAZA DR.

6 STA. 0+00
MONTANO RD. N.W.

6 STA. 0+00
MONTANO RD. N.W.

6 STA. 3+44.26
MONTANO PLAZA DR.

6 STA. 0+00
MONTANO RD. N.W.

6 STA. 0+00
MONTANO RD. N.W.

6 STA. 3+44.26
MONTANO PLAZA DR.

6 STA. 0+00
MONTANO RD. N.W.

6 STA. 0+00
MONTANO RD. N.W.

6 STA. 3+44.26
MONTANO PLAZA DR.

6 STA. 0+00
MONTANO RD. N.W.

6 STA. 0+00
MONTANO RD. N.W.

6 STA. 3+44.26
MONTANO PLAZA DR.

6 STA. 0+00
MONTANO RD. N.W.

6 STA. 0+00
MONTANO RD. N.W.

6 STA. 3+44.26
MONTANO PLAZA DR.

6 STA. 0+00
MONTANO RD. N.W.

6 STA. 0+00
MONTANO RD. N.W.

6 STA. 3+44.26
MONTANO PLAZA DR.

6 STA. 0+00
MONTANO RD. N.W.

6 STA. 0+00
MONTANO RD. N.W.

6 STA. 3+44.26
MONTANO PLAZA DR.

6 STA. 0+00
MONTANO RD. N.W.

6 STA. 0+00
MONTANO RD. N.W.

6 STA. 3+44.26
MONTANO PLAZA DR.

6 STA. 0+00
MONTANO RD. N.W.

6 STA. 0+00
MONTANO RD. N.W.

6 STA. 3+44.26
MONTANO PLAZA DR.

6 STA. 0+00
MONTANO RD. N.W.

6 STA. 0+00
MONTANO RD. N.W.

6 STA. 3+44.26
MONTANO PLAZA DR.

6 STA. 0+00
MONTANO RD. N.W.

6 STA. 0+00
MONTANO RD. N.W.

6 STA. 3+44.26
MONTANO PLAZA DR.

6 STA. 0+00
MONTANO RD. N.W.

6 STA. 0+00
MONTANO RD. N.W.

6 STA. 3+44.26
MONTANO PLAZA DR.

6 STA. 0+00
MONTANO RD. N.W.

6 STA. 0+00
MONTANO RD. N.W.

6 STA. 3+44.26
MONTANO PLAZA DR.

6 STA. 0+00
MONTANO RD. N.W.

6 STA. 0+00
MONTANO RD. N.W.

6 STA. 3+44.26
MONTANO PLAZA DR.

6 STA. 0+00
MONTANO RD. N.W.

6 STA. 0+00
MONTANO RD. N.W.

6 STA. 3+44.26
MONTANO PLAZA DR.

6 STA. 0+00
MONTANO RD. N.W.

6 STA. 0+00
MONTANO RD. N.W.

6 STA. 3+44.26
MONTANO PLAZA DR.

6 STA. 0+00
MONTANO RD. N.W.

6 STA. 0+00
MONTANO RD. N.W.

6 STA. 3+44.26
MONTANO PLAZA DR.

6 STA. 0+00
MONTANO RD. N.W.

6 STA. 0+00
MONTANO RD. N.W.

6 STA. 3+44.26
MONTANO PLAZA DR.

6 STA. 0+00
MONTANO RD. N.W.

6 STA. 0+00
MONTANO RD. N.W.

6 STA. 3+44.26
MONTANO PLAZA DR.

6 STA. 0+00
MONTANO RD. N.W.

6 STA. 0+00
MONTANO RD. N.W.

EXIST. WATER LINE & VALVE
EXIST. SANITARY SEWER & MAN-
HOLE
EXIST. UNDERGROUND ELECTRIC
EXIST. RIGHT-OF-WAY
EXIST. GAS LINE
PROP. WATER LINE
PROP. WATER VALVE
PROP. FIRE HYDRANT
(PER CITY STD. DWG. 20)
PROP. WATER METER
(PER CITY STD. DWG. W-11, W-12, W-17, W-19)
PROP. PRIVATE SAN SEWER &
MANHOLE
UTILITY EASEMENT
EXIST. FIRE HYDRANT
PROP. 6" SAS SERVICE LINE
W/ CLEANOUT (DETAIL ON
SHT. 6)

LEGEND

GENERAL NOTES - ALL UTILITY SHEETS

- THE CONTRACTOR SHALL FURNISH ELDS ON ALL WATER AND SEWER SERVICE STUBS, CAPS AND PLUGS.
- ALL STATIONING REFERS TO AISLE CENTERLINE.
- CONTRACTOR SHALL FIELD VERIFY LOCATIONS AND ELEVATIONS OF ALL EXISTING PIPE AND UTILITIES PRIOR TO CONSTRUCTION.
- WATER SERVICES SHALL BE 1 1/2" OR 2" DIAMETER AS SHOWN ON PLAN. TYPE K COPPER TUBING CLASS 160, WITH 1 1/2" OR 2" METERS RESPECTIVELY.
- ALL TEES BENDS AND CAPS SHALL BE BLOCKED ACCORDING TO CITY OF ALBUQUERQUE STANDARDS.
- ALL PIPE SHALL BE FURNISHED WITH CLASS "C" BEDDING UNLESS OTHERWISE NOTED.
- ALL TRENCH BACKFILL SHALL BE COMPACTED TO A MINIMUM OF 90% OF OPTIMUM (MODIFIED).
- WATER PIPE SHALL BE P.V.C. CLASS 150 AWWA C900. SEWER PIPE SHALL BE P.V.C. CLASS SDR35.
- ALL PVC WATERMAIN FITTINGS SHALL BE "GRIP-TIGHT" PUSH-ON TYPE FITTINGS - AWWA APPROVED FOR PVC, C900 WATERMAIN.
- WATER AND SEWER SERVICES SHALL BE INSTALLED ACCORDING TO THE CITY OF ALBUQUERQUE STANDARDS.
- ALL MANHOLES SHALL BE TYPE "E" PER STD. DWGS. S-6-1 W/ 4' DIAMETER.
- SEWER LINE SHOWN SHALL BE A PRIVATE SYSTEM AND IS NOT A PART OF THIS WORK ORDER.
- ALL CLEANOUT RISERS SHALL BE CONSTRUCTED OF CAST IRON PIPE AND SHALL BE PLACED WITHIN A 12" CONCRETE COLLAR AT FINISHED GRADE AS SHOWN HEREON.
- ALL EXIST. PAVEMENT REMOVALS SHALL BE CONDUCTED BY SAWCUTTING ALONG A STRAIGHT LINE TO A MIN. DEPTH OF 2".

CITY OF ALBUQUERQUE
MUNICIPAL DEVELOPMENT DEPARTMENT
ENGINEERING DIVISION

TITLE SOMBRA DEL OSO APARTMENTS

UTILITY COMPOSITE


ENGINEER	DATE	APPROVALS	ENGINEER	DATE
ACE Design	3/11/02	Liquid Waste	NAB/BJL	2-13-02
ACE Hydrology	3/11/02	Traffic	N/A/BJL	2-12-02
		Water	BJL	2-13-02

DRAWING NO. 2745 MAP NO. E-12-Z SHEET 6 OF 15



ADDED CLEANOUT ON LINE A,B,H,I,F
F.H. LOCATION
REVISED WIDTHS OF PARKING LOTSI
AISLES 'B','C','E'

NO.	DATE	REVISIONS	DESIGN	DATE	CHECKED BY	DATE
1			P.A.			
2			M.Y.			

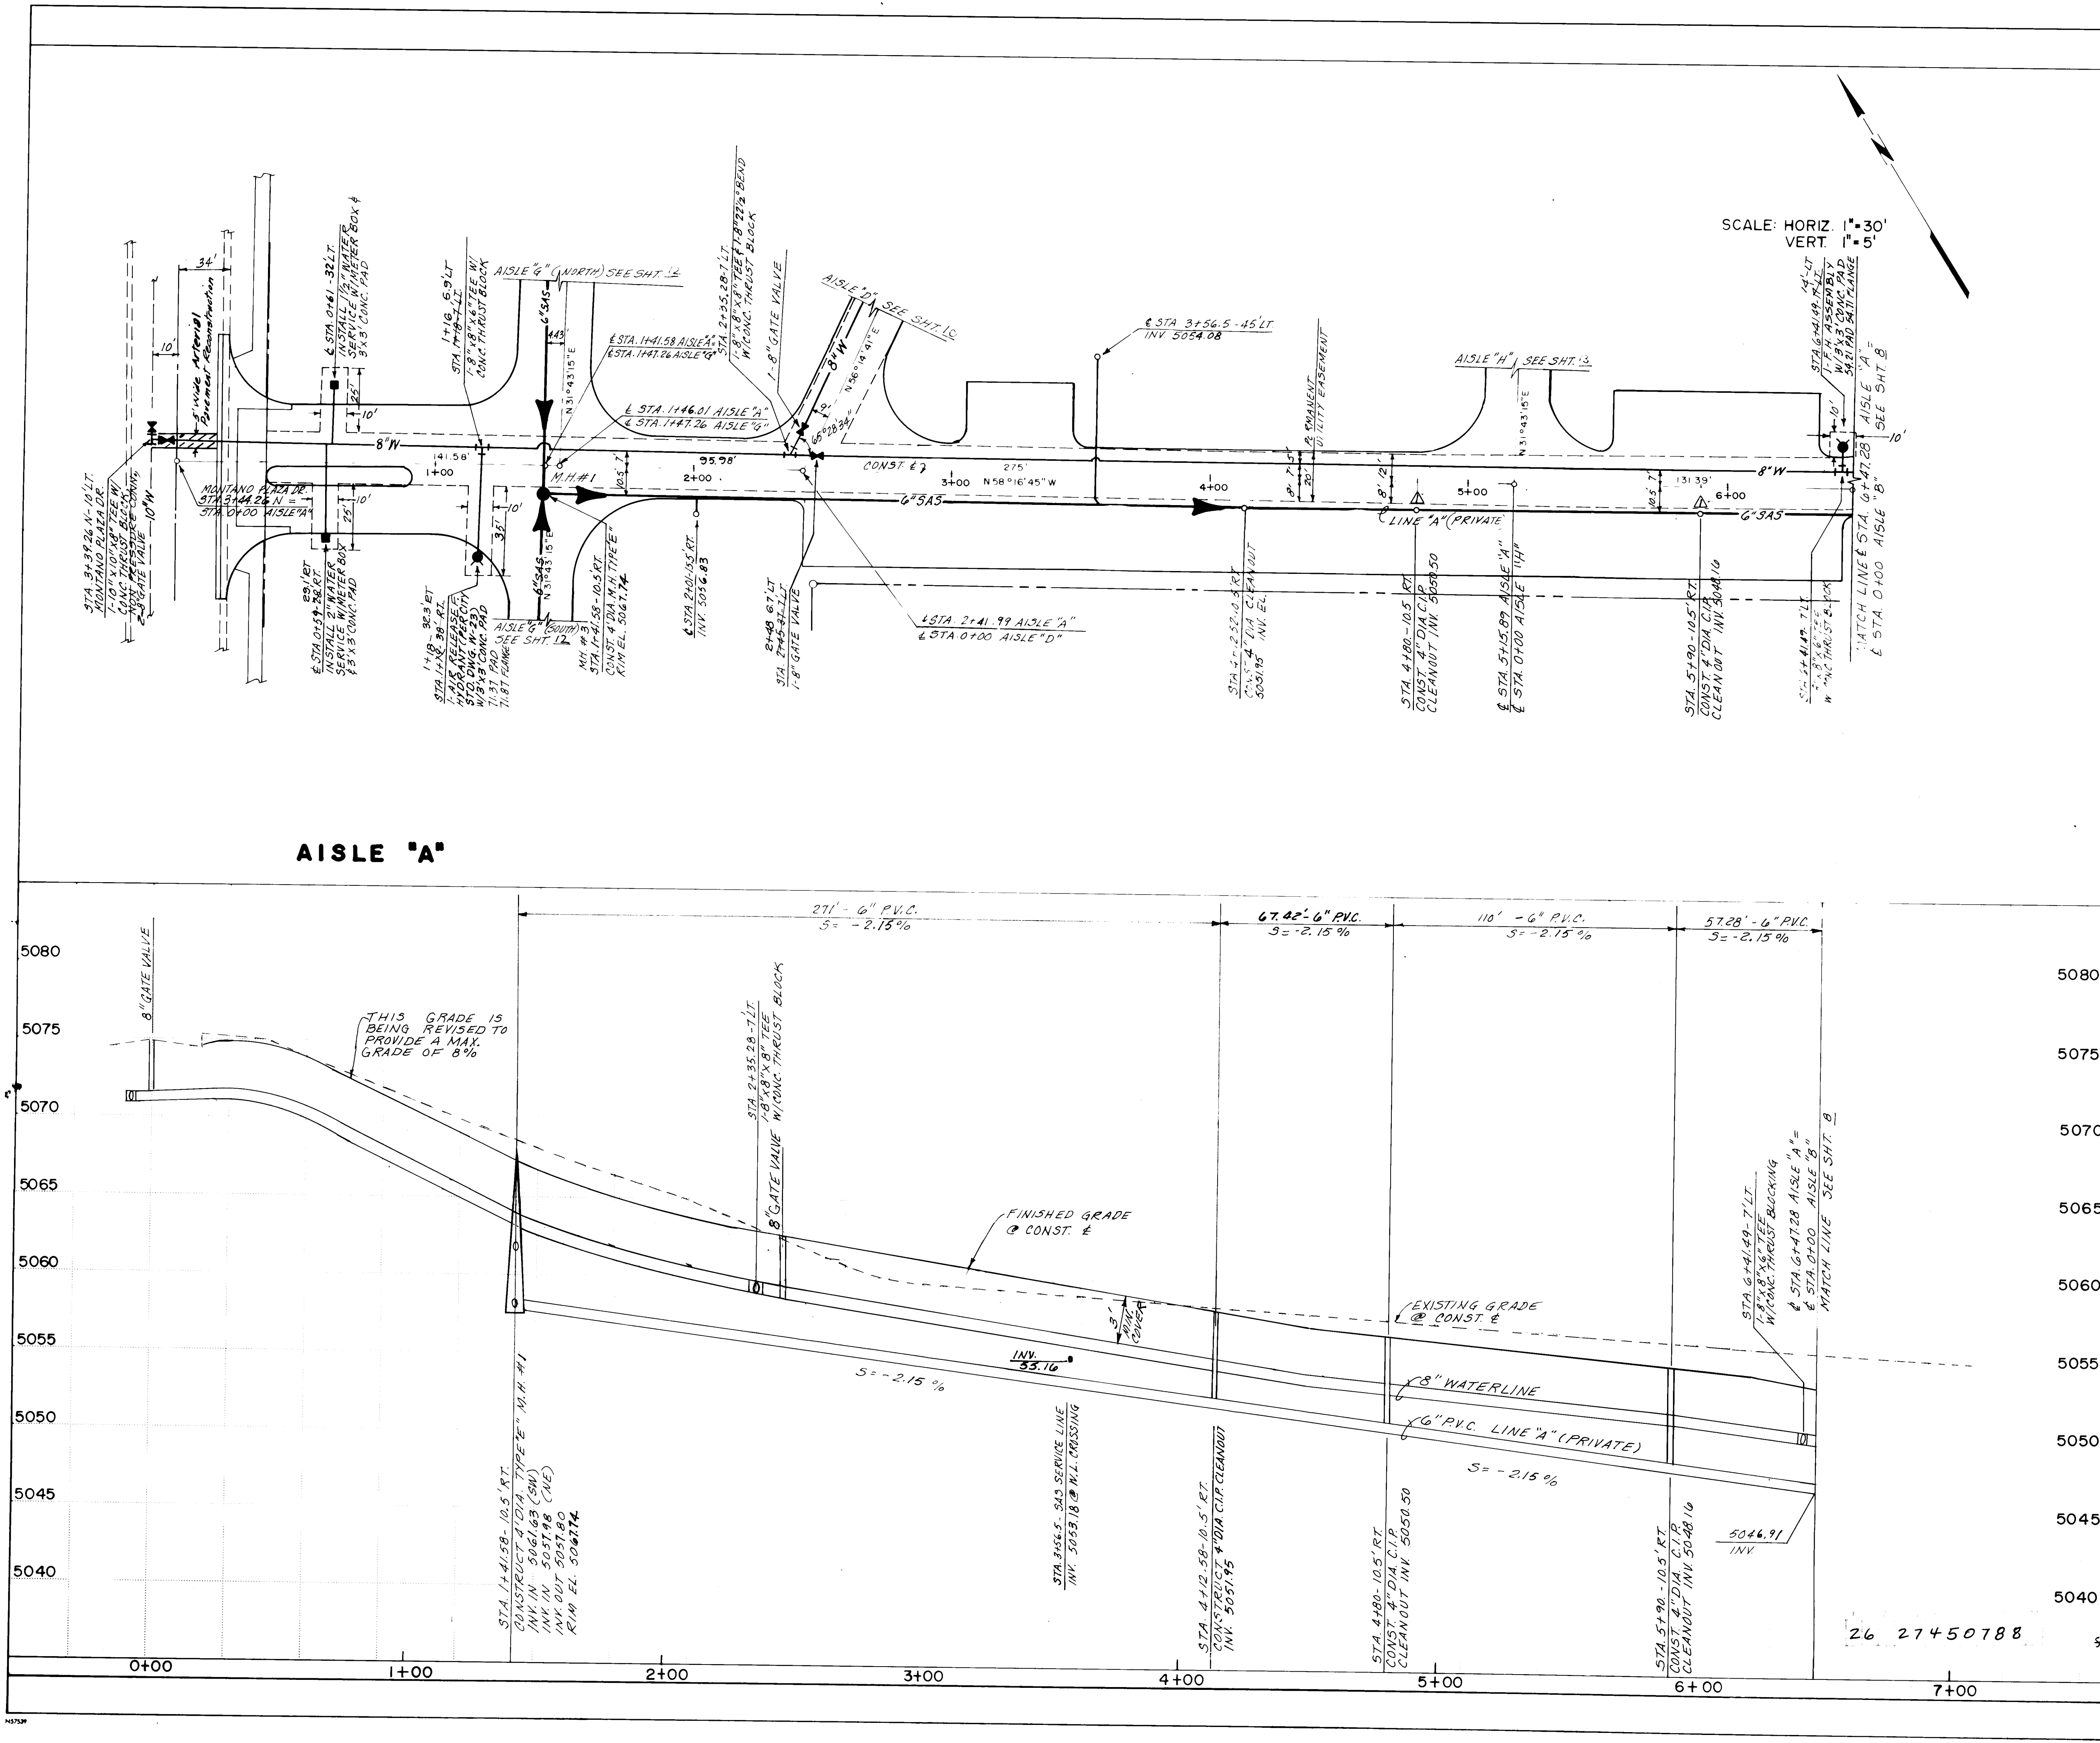

RECORD DRAWING

The water line shown on this drawing has been as-built in accordance with field surveys performed by Espey, Huston and Associates, Inc. and information provided by Construction Contracting and Management, Inc. (Contractors) to reflect conditions actually accomplished as of this date, to the best of my knowledge and belief.

Jim Leyman, Jr., P.E. 8105

Date 7/16/06

SCALE: HORIZ. 1"=30'
VERT. 1"=5'

LEGEND

PROPOSED PRIVATE SEWER LINE & M.H. (PER CITY STD. DWG. S-2, S-5)

UTILITY EASEMENT

PROP. 6" SAS PRIVATE SERVICE LINE W/CLEANOUT (DETAIL ON SHT. 6)

EXIST. TELEPHONE BOX

EXIST. GAS REGULATOR

EXIST. GAS

EXIST. WATER & VALVE

EXIST. SANITARY SEWER & MANHOLE

EXIST. STORM DRAIN & MANHOLE

EXIST. UNDERGROUND ELECTRIC

EXIST. UNDERGROUND TELEPHONE

EXIST. UNDERGROUND CABLE TV

EXIST. CABLE TV BOX

EXIST. FENCE

EXIST. RIGHT OF WAY

EXIST. POWER POLE

PROP. WATER VALVE

PROP. FIRE HYDRANT (PER CITY STD. DWG. 20)

PROP. WATER METER (PER CITY STD. DWG. W-11, W-12, W-13)

NEW STORM DRAIN

NEW STORM DRAIN MANHOLE

NEW STORM DRAIN INLET (PER CITY STD. DWG. A-1, K-2, K-5)

JUNCTION BOX

REINF. CONCRETE PIPE

HIGH PRESSURE GAS LINE

VERY HIGH PRESSURE GAS LINE

TOP OF DRIVEPAD

FINISHED FLOOR

DRIVE WAY

TOP OF GRATE

TOP OF CURB

TOP OF SIDEWALK

FLOW LINE

CAST IRON PIPE

CLEANOUT

ENGINEER'S SEAL

CLIFFORD D. GARDNER, P.E. 5853

Signature: Clifford D. Gardner

AS BUILT INFORMATION

B.M. - N.H. COR. SEC. 26, T. 11N, R. 2E, N.M.P.M. BRASS

CAP FOUND IN PLACE, NEW MEXICO STATE PLANE

COORDINATE SYSTEM (CENTRAL ZONE)

X = 367,944.77 Y = 1513,731.59 ELEV. = 5112.53'

T.B.M. - SET @ 11.5' BACK OF CURB @ N.E. COR. OF INTERSECTION OF MONTANO RD. & MONTANO PLAZA DR. N.W. ELEV. 5071.73'

REVISIONS

NO.	DATE	REMARKS
1	5-14-06	100% CLEANOUT @ STA 4+400.5+70
2	5-28-06	REVISED GRADE & WATER LINE STA 1+25 TO STA 4+150

DESIGN

DESIGNED BY	DATE	CHECKED BY	DATE
PA	11-26-05	MY	11-27-05

CITY OF ALBUQUERQUE
MUNICIPAL DEVELOPMENT DEPARTMENT
ENGINEERING DIVISION

TITLE: SOMBRA DEL OSO APARTMENTS AISLE "A"


UTILITIES PLAN & PROFILE

APPROVALS	ENGINEER	DATE	APPROVALS	ENGINEER	DATE
City Engineer	Jim Leyman	5/11/06	Liquid Waste	N/A	2-13-06
A.C.E. - Design	Jim Leyman	3/1/06	Traffic	N/A	2/12/06
A.C.E. - Hydrology	Jim Leyman	3/1/06	Water	N/A	2-13-06

DRAWING NO. **2745**

MAP NO. **E-12-Z**

SHEET **7** OF **15**

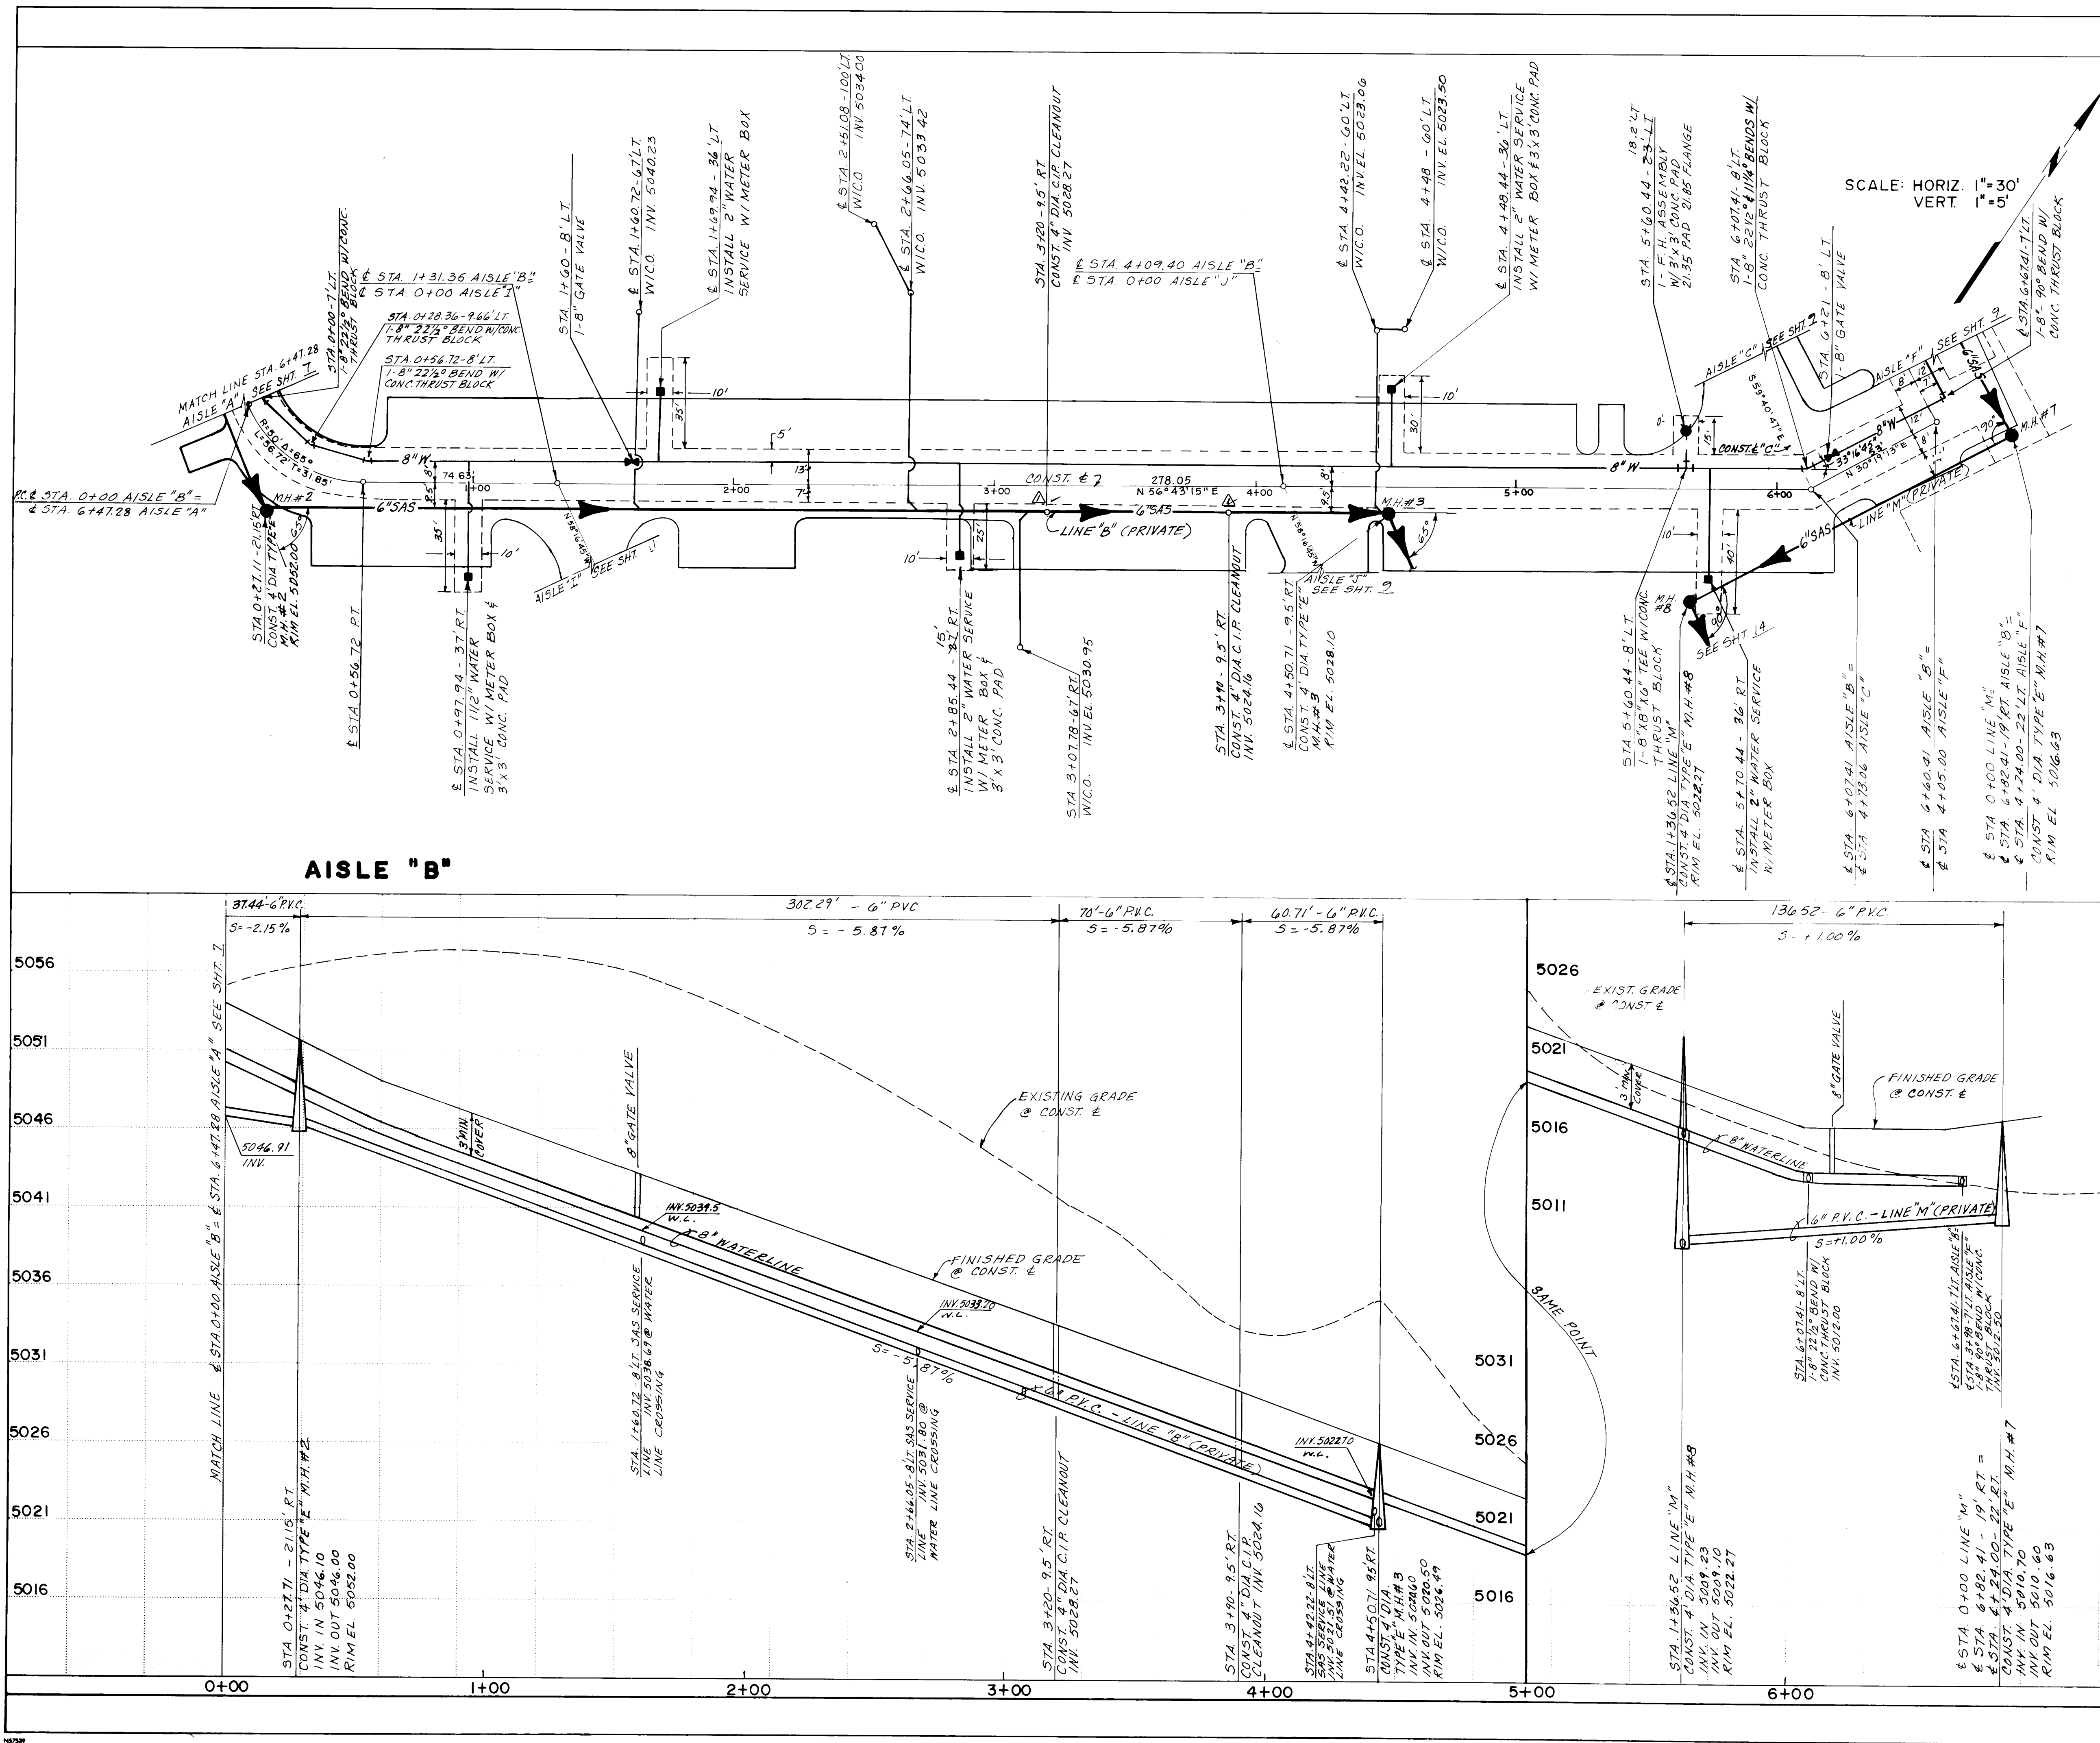

RECORD DRAWING

The water line shown on this drawing has been as-built in accordance with field surveys performed by Espey, Huston and Associates, Inc. (contractors) to reflect construction actually accomplished as of this date, to the best of my knowledge and belief.

Jim Leyman, P.E., P.E. 8105

Date 7/10/84

LEGEND

PROPOSED PRIVATE SEWER LINE & M.H. (PER CITY STD. DWG. S-2, S-5)

UTILITY EASEMENT

PROP. 6" SAS PRIVATE SERVICE LINE W/CLEANOUT (DETAIL ON SHT. 6)

EXIST. TELEPHONE BOX

EXIST. GAS REGULATOR

EXIST. GAS

EXIST. WATER & VALVE

EXIST. SANITARY SEWER & MANHOLE

EXIST. STORM DRAIN & MANHOLE

EXIST. UNDERGROUND ELECTRIC

EXIST. UNDERGROUND TELEPHONE

EXIST. UNDERGROUND CABLE TV

EXIST. CABLE TV BOX

EXIST. FENCE

EXIST. RIGHT OF WAY

EXIST. POWER POLE

PROP. WATER LINE

PROP. WATER VALVE

PROP. FIRE HYDRANT (PER STD. DWG. W-20)

PROP. WATER METER

NEW STORM DRAIN

NEW STORM DRAIN MANHOLE

NEW STORM DRAIN INLET (PER STD. DWG. K-1, K-2, K-5)

JUNCTION BOX

REINF. CONCRETE PIPE

HIGH PRESSURE GAS LINE

VERY HIGH PRESSURE GAS LINE

TOP OF DRIVEPAD

FINISHED FLOOR

DRIVE WAY

TOP OF GRATE

TOP OF CURB

TOP OF SIDEWALK

FLOW LINE

CAST IRON PIPE

CLEANOUT

ENGINEER'S SEAL

NO. DATE

REMARKS

DESIGN

DESIGNED BY P4

DRAWN BY B.J.G.

CHECKED BY

DATE 11-20-85

DATE 11-27-85

CITY OF ALBUQUERQUE

MUNICIPAL DEVELOPMENT DEPARTMENT

ENGINEERING DIVISION

TITLE: SOMBRA DEL OSO APARTMENTS

AISLE "B"



UTILITIES PLAN & PROFILE

APPROVALS	ENGINEER	DATE	APPROVALS	ENGINEER	DATE
City Engineer	Jim Leyman	7/11/84	Liquid Waste	NAB R	2-13-84
ACE - Design	Jim Leyman	7/11/84	Traffic	NAB R	7/12/84
ACE - Hydrology	Jim Leyman	7/11/84	Water	BRG	2-13-84

DRAWING NO. 2745

MAP NO. E-12-Z

SHEET 8 OF 15

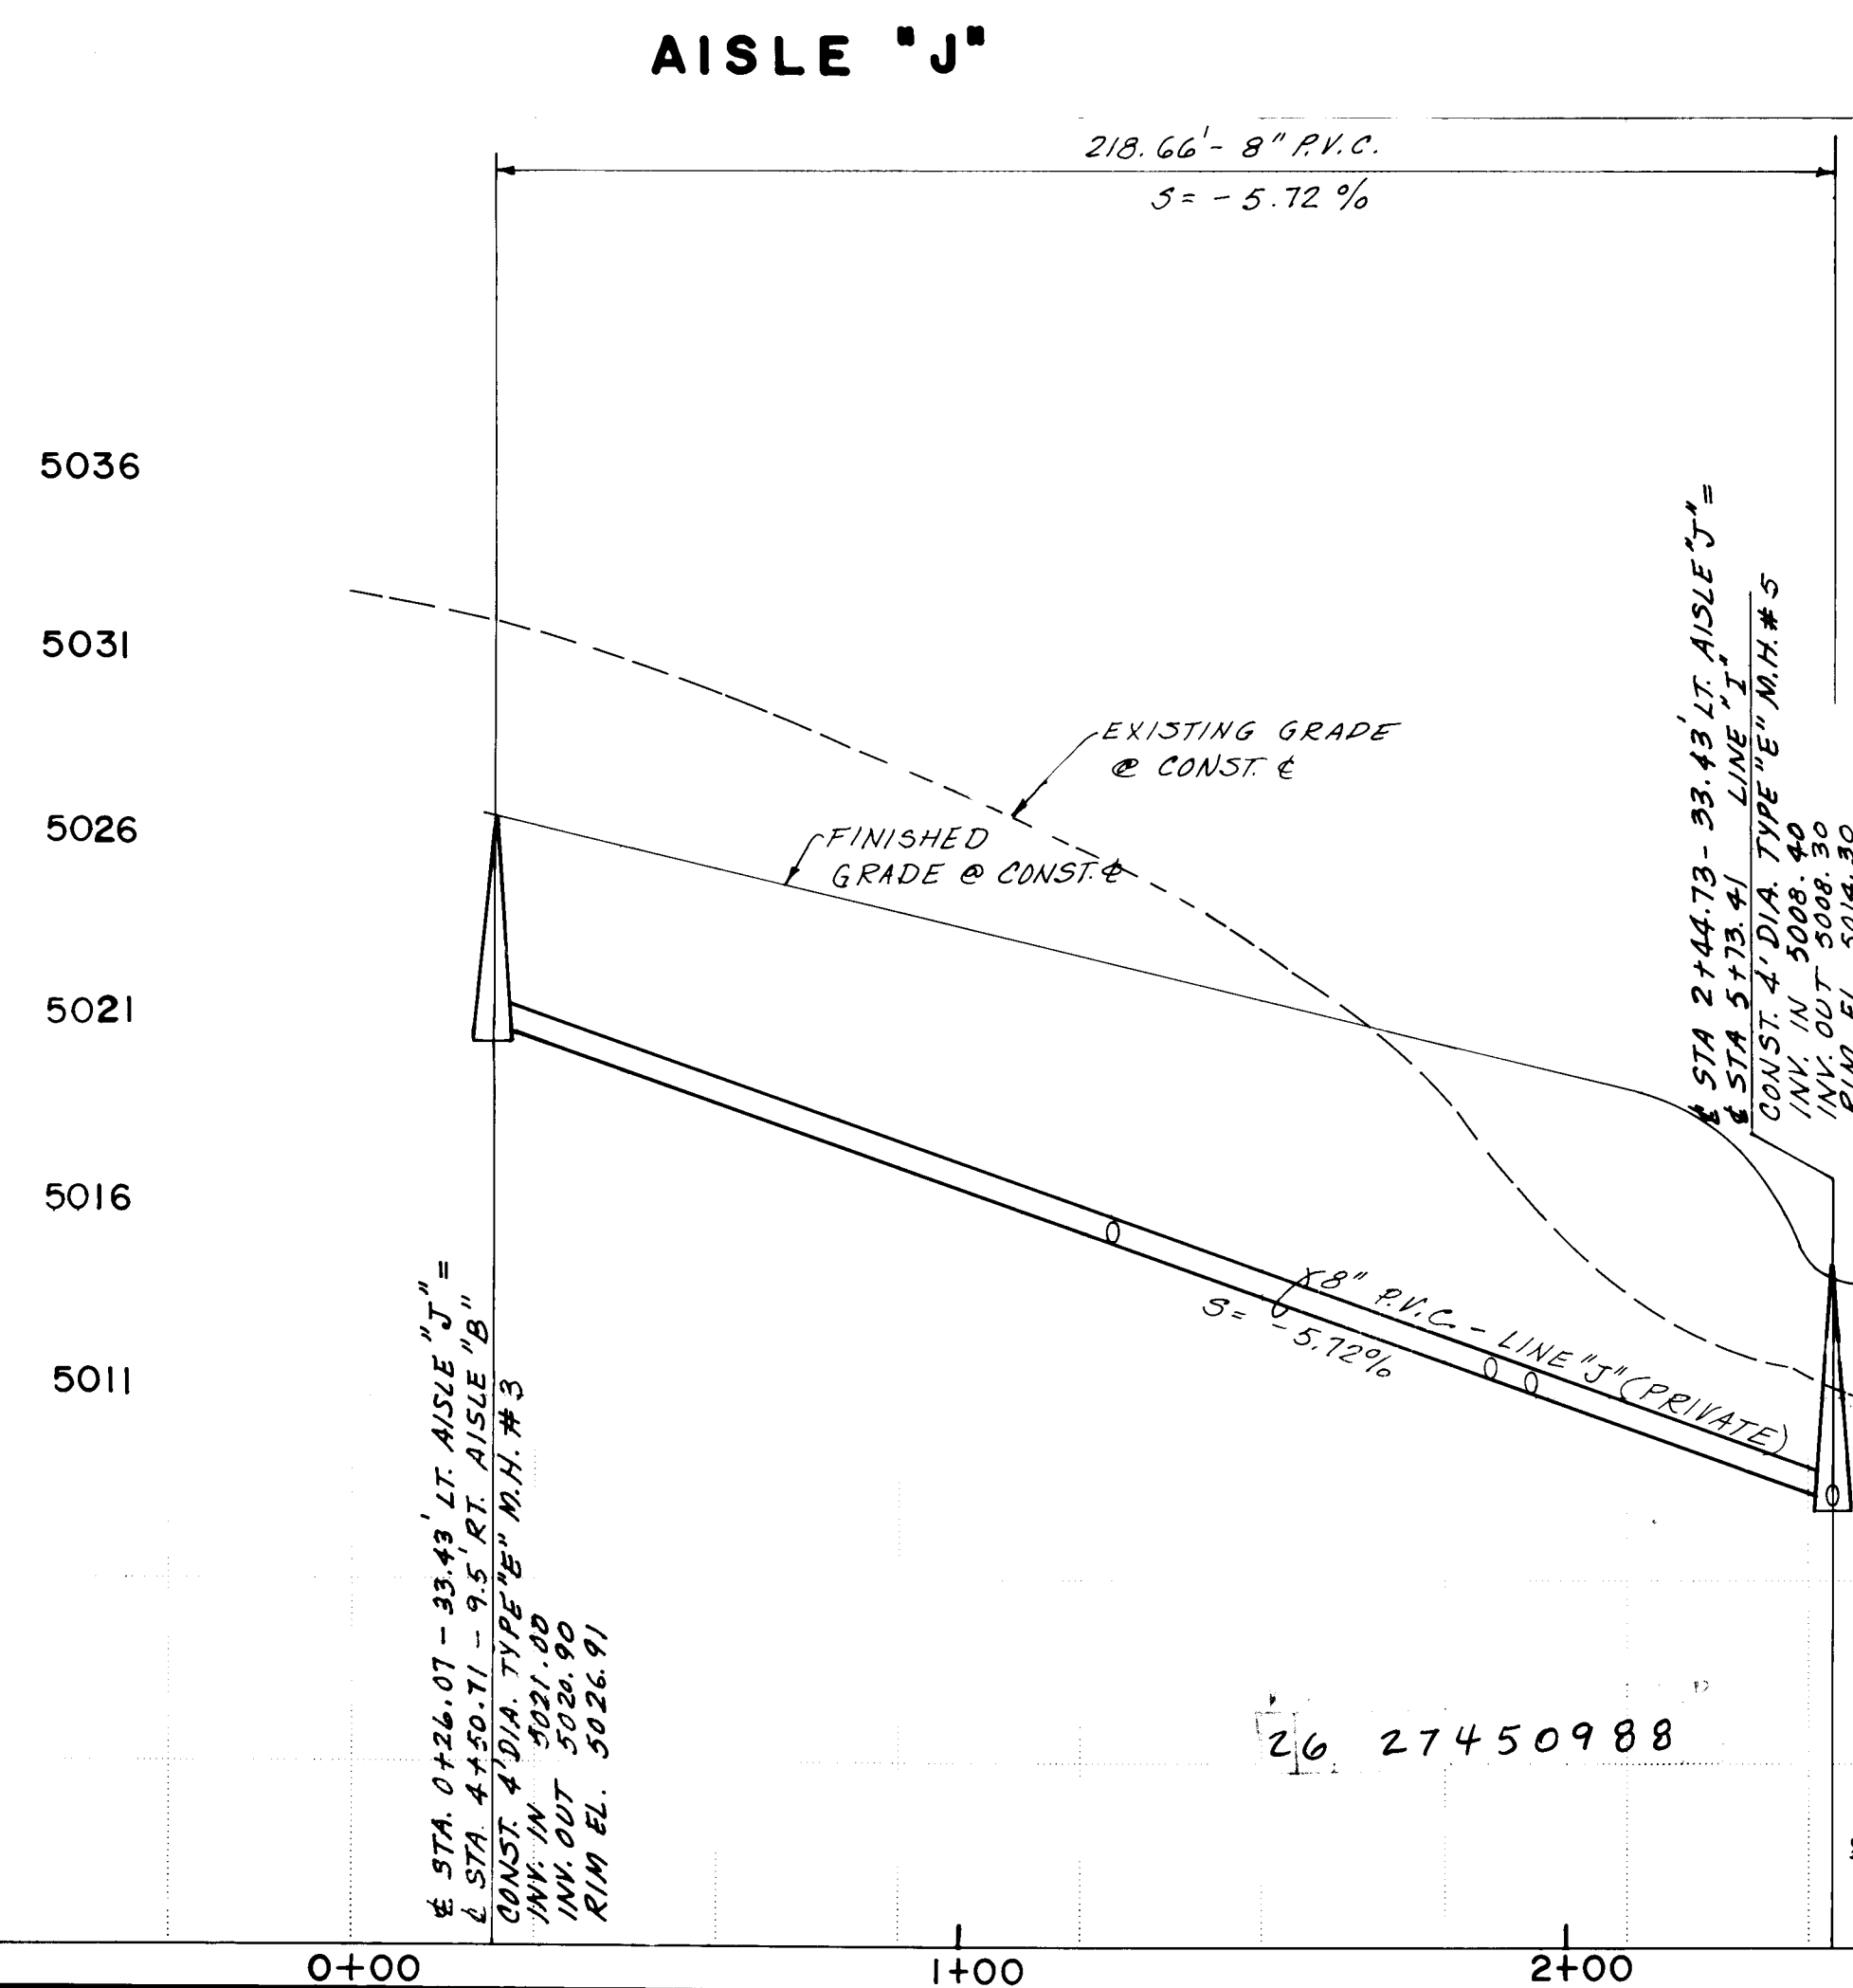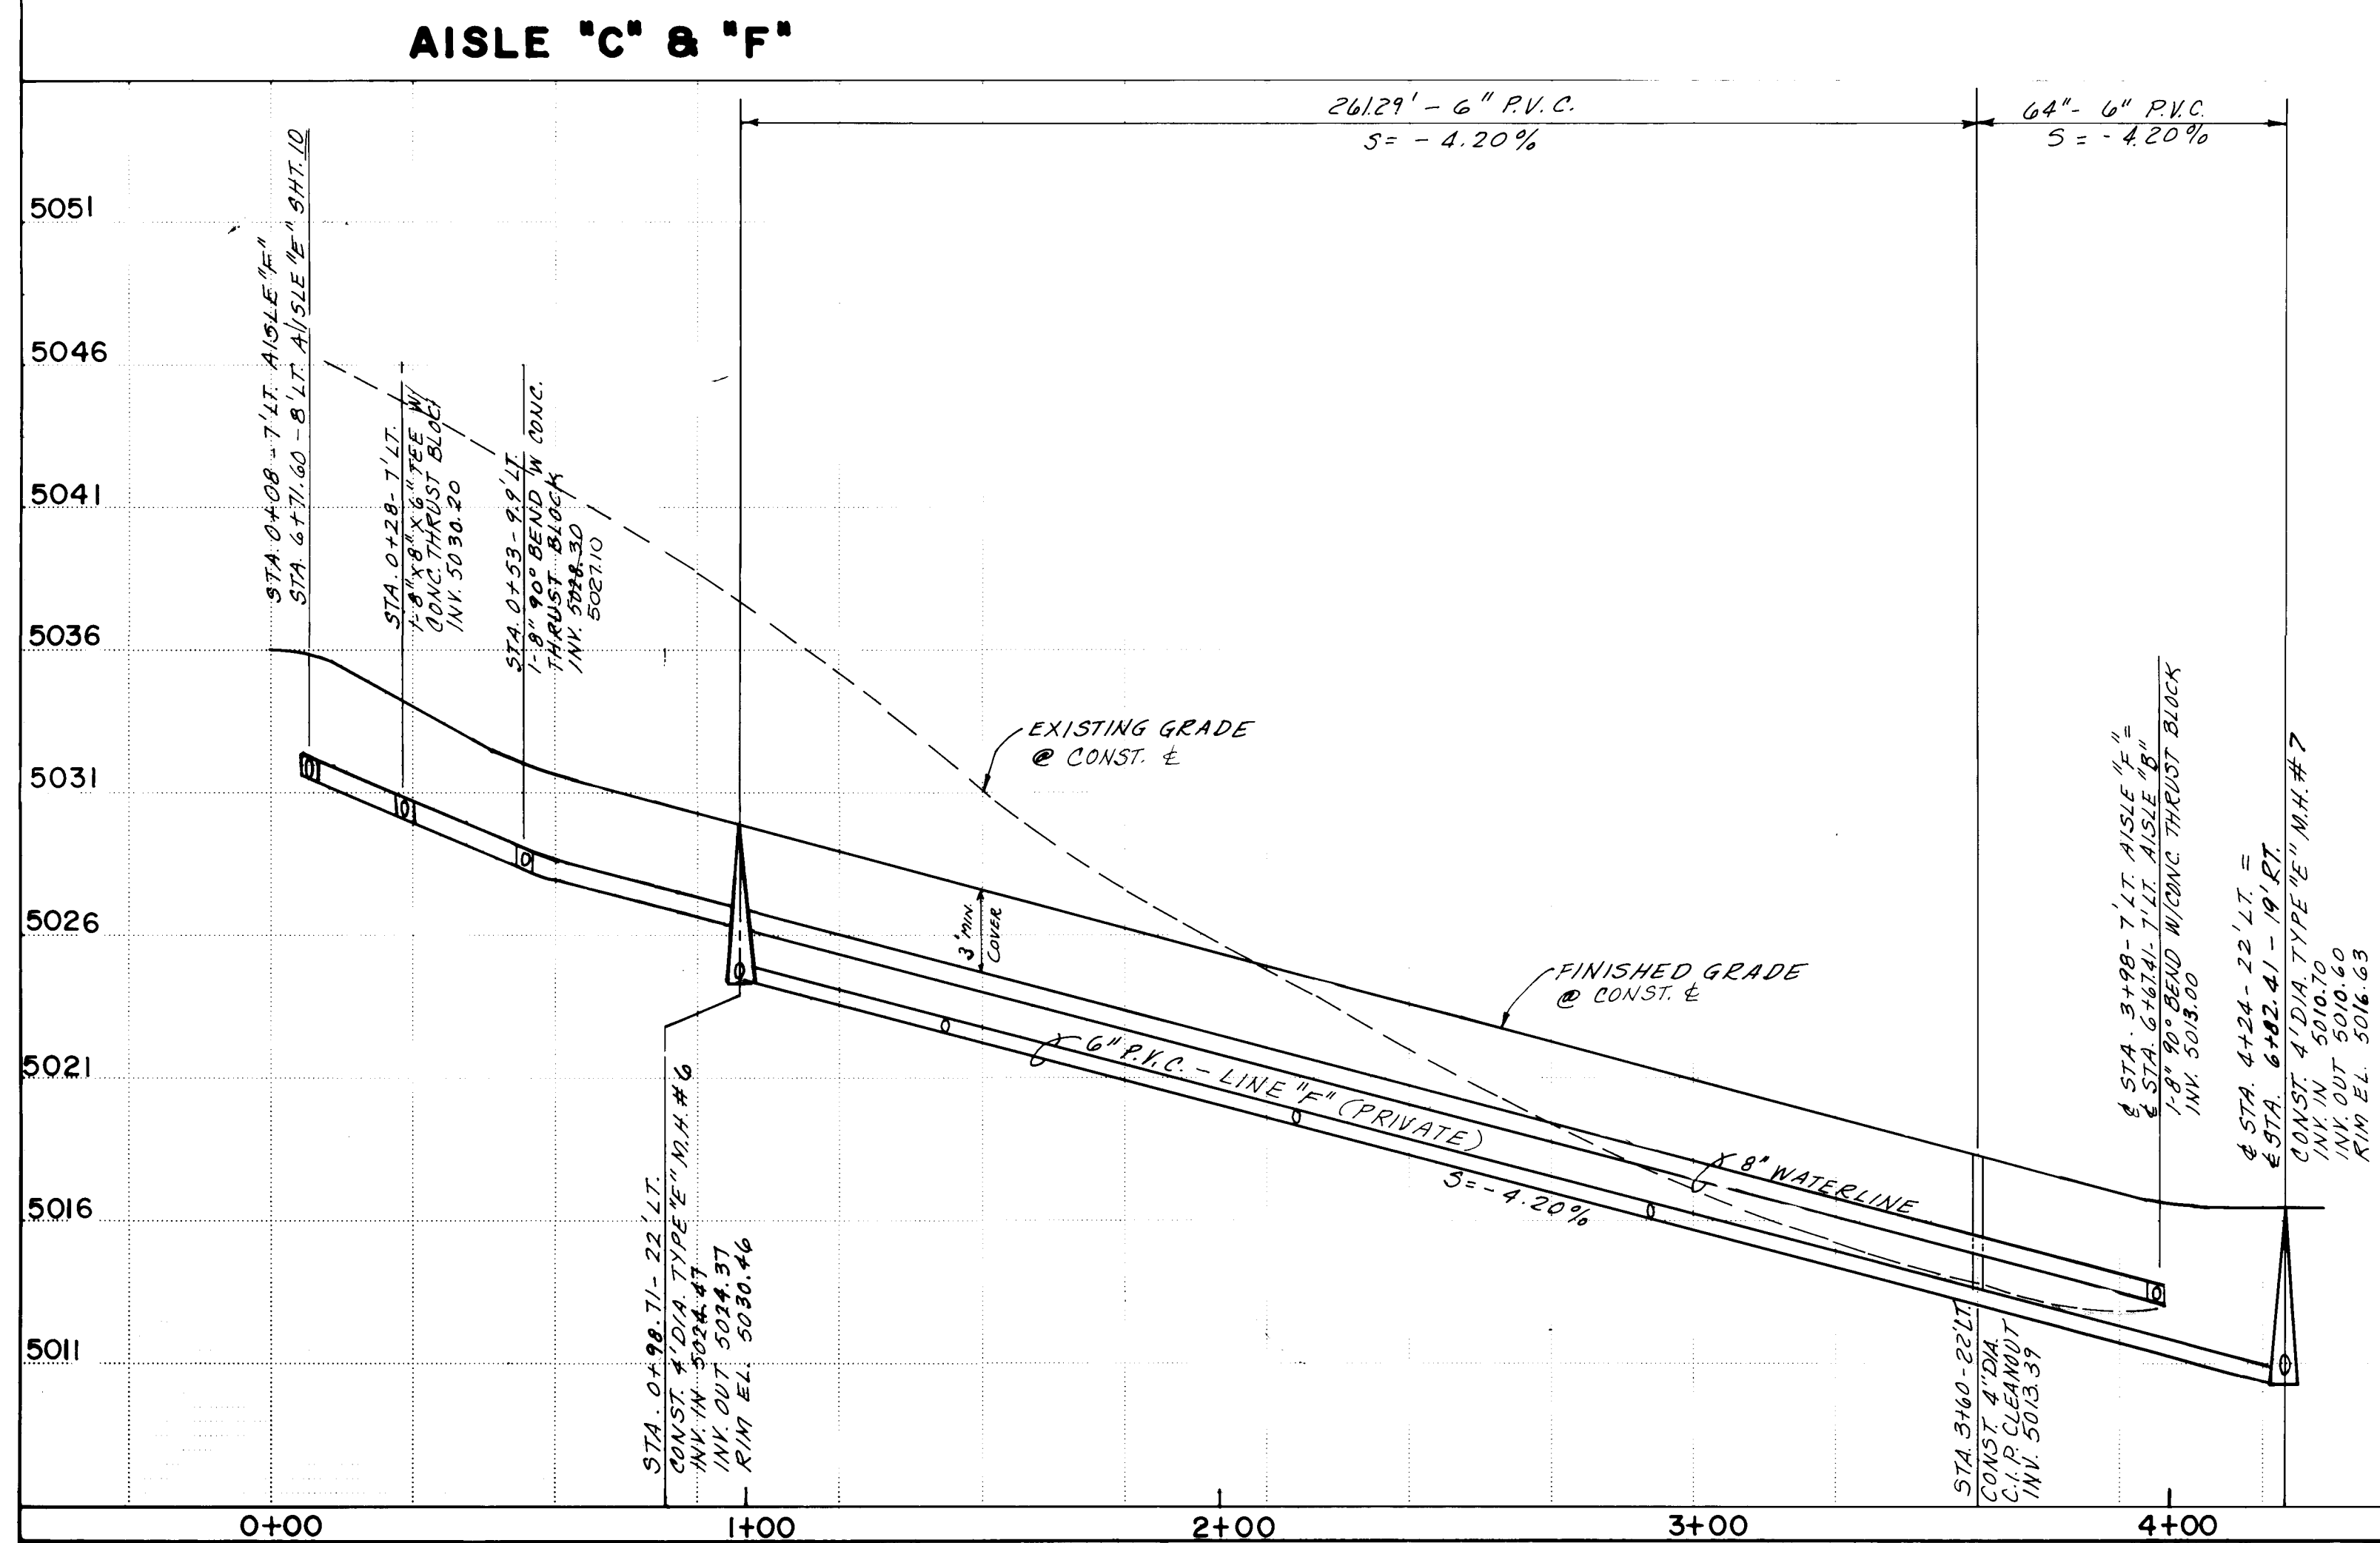


RECORD DRAWING

The water line shown on this drawing has been as-built in accordance with field surveys performed by Espey, Huston and Associates, Inc. (contractors) and information provided by Construction Contracting and Management, Inc. (contractors) to reflect construction actually accomplished as of this date, to the best of my knowledge and belief.

Jim Leyman, Jr., P.E. 8105
Leyman
Date

1997, 1998, 1999, 2678, 26

DRAWING NO.	2745	MAP NO.	E-12-Z	SHEET	9	OF	15
-------------	------	---------	--------	-------	---	----	----

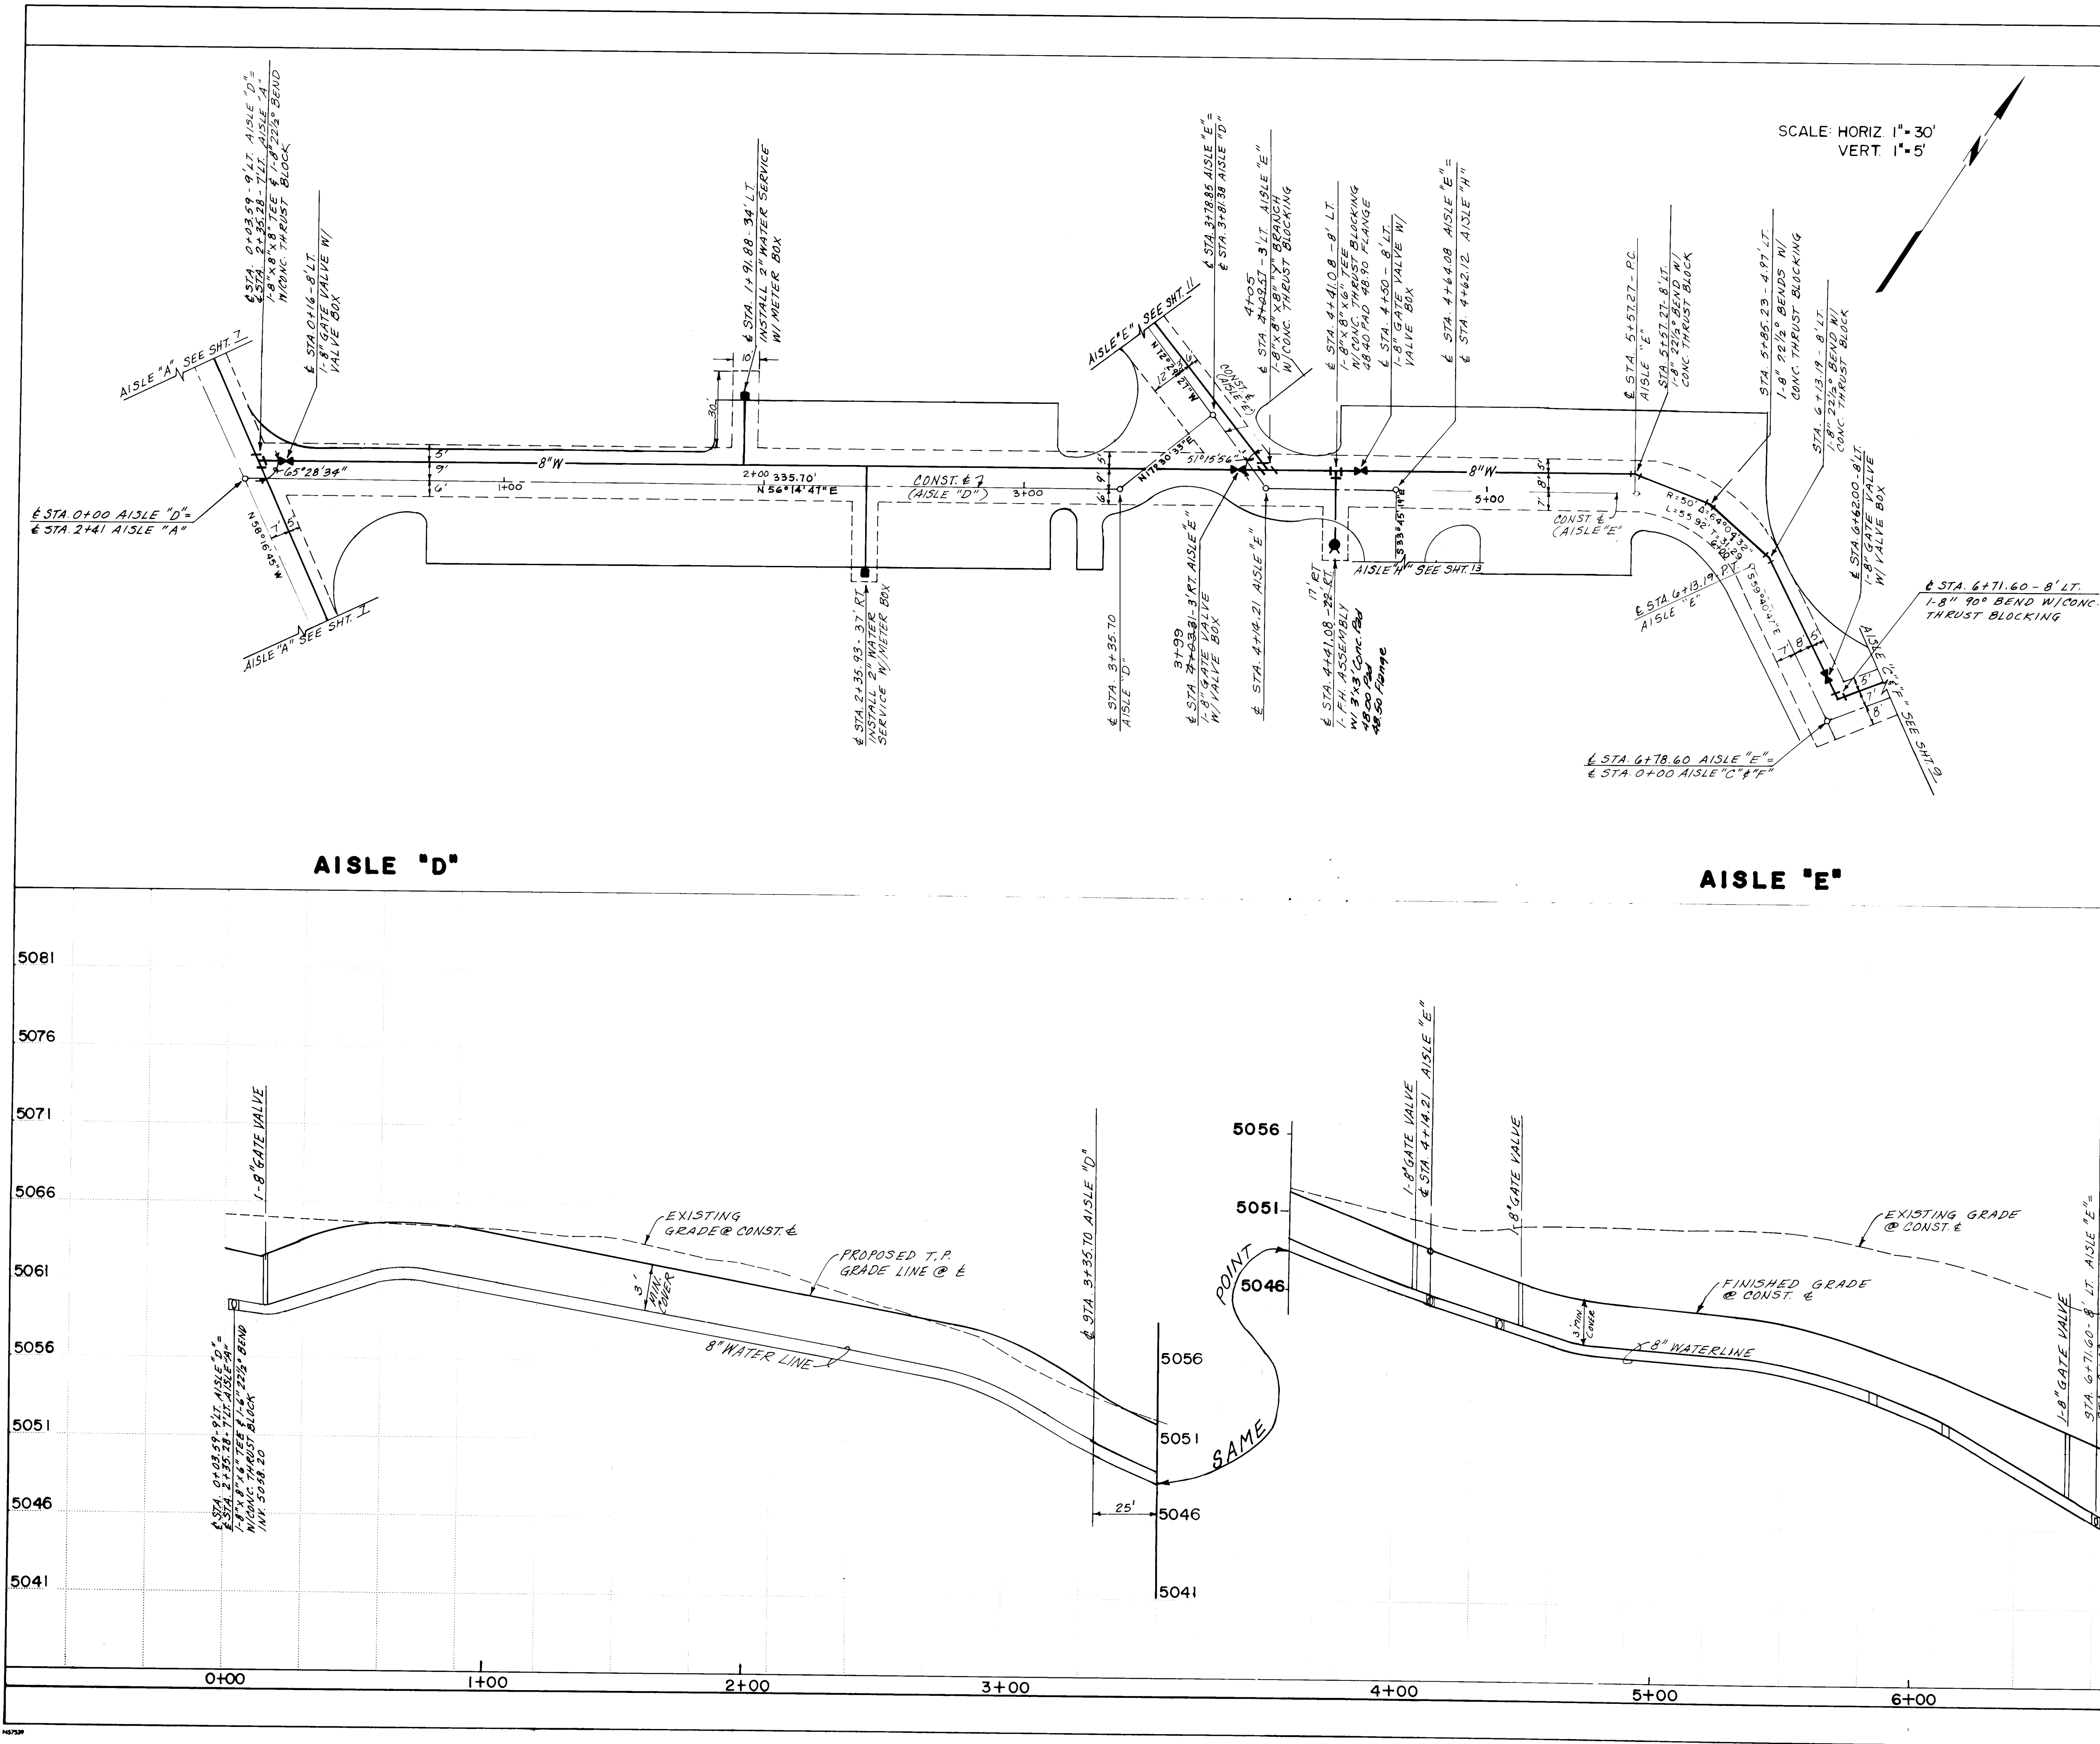

RECORD DRAWING

The water line shown on this drawing has been as-built in accordance with field survey data provided by the City of Albuquerque, New Mexico. The information provided by the City of Albuquerque, New Mexico, is the basis for the construction of this drawing. The Engineer, Jim Leyman, Jr., P.E., is not responsible for the accuracy of the information provided by the City of Albuquerque, New Mexico, or for the construction of this drawing.

JIM LEYMAN, JR., P.E.
 7/10/86
 Date

AS BUILT INFORMATION

DATE	BY	REVISIONS
7/10/86	JIM LEYMAN, JR., P.E.	AS BUILT



ENGINEER'S SEAL

CITY OF ALBUQUERQUE
MUNICIPAL DEVELOPMENT DEPARTMENT
ENGINEERING DIVISION

TITLE: SOMBRA DEL OSO APARTMENTS
AISLE "D" & AISLE "E"
UTILITIES PLAN & PROFILE

APPROVALS	ENGINEER	DATE	APPROVALS	ENGINEER	DATE
City Engineer	Jim Leyman, Jr., P.E.	3/11/86	Liquid Waste	N/A	2-13-86
A.C.E. Design	Jim Leyman, Jr., P.E.	3/11/86	Traffic	N/A	3/12/86
A.C.E. Hydrology	Jim Leyman, Jr., P.E.	3/11/86	Water	N/A	2-13-86


DRAWING NO. 2745
MAP NO. E-12-Z
SHEET 10 OF 15

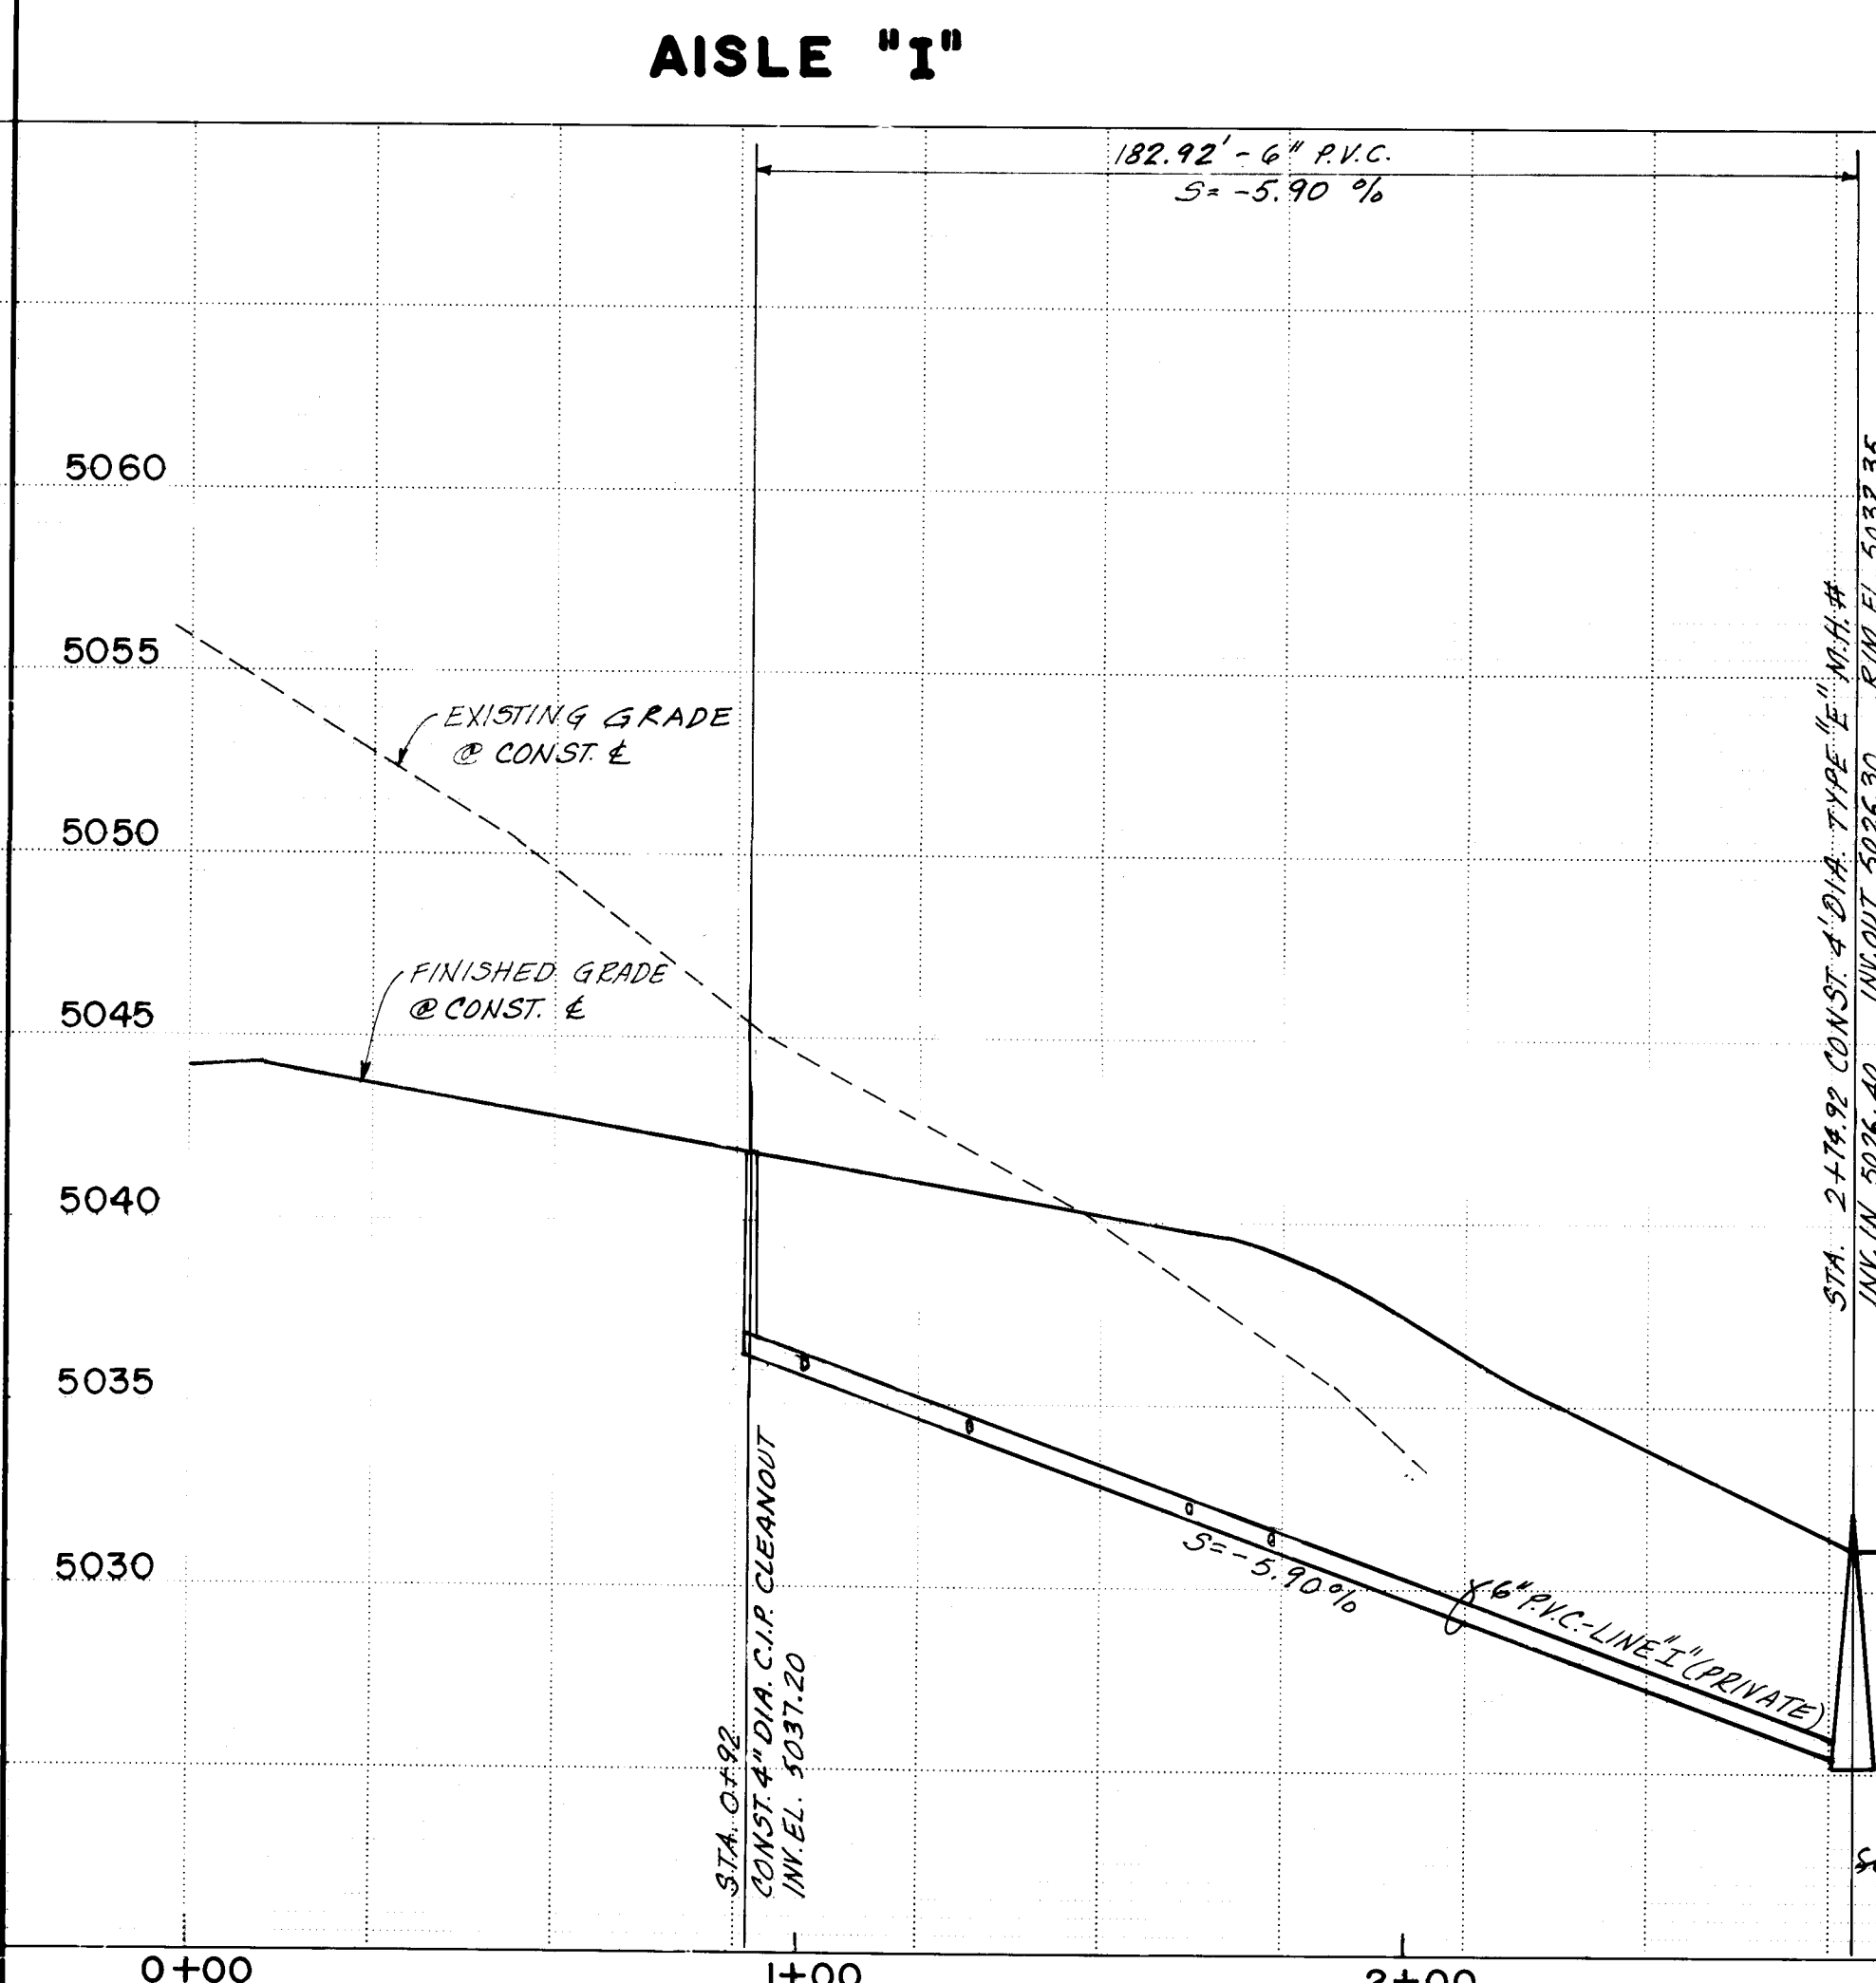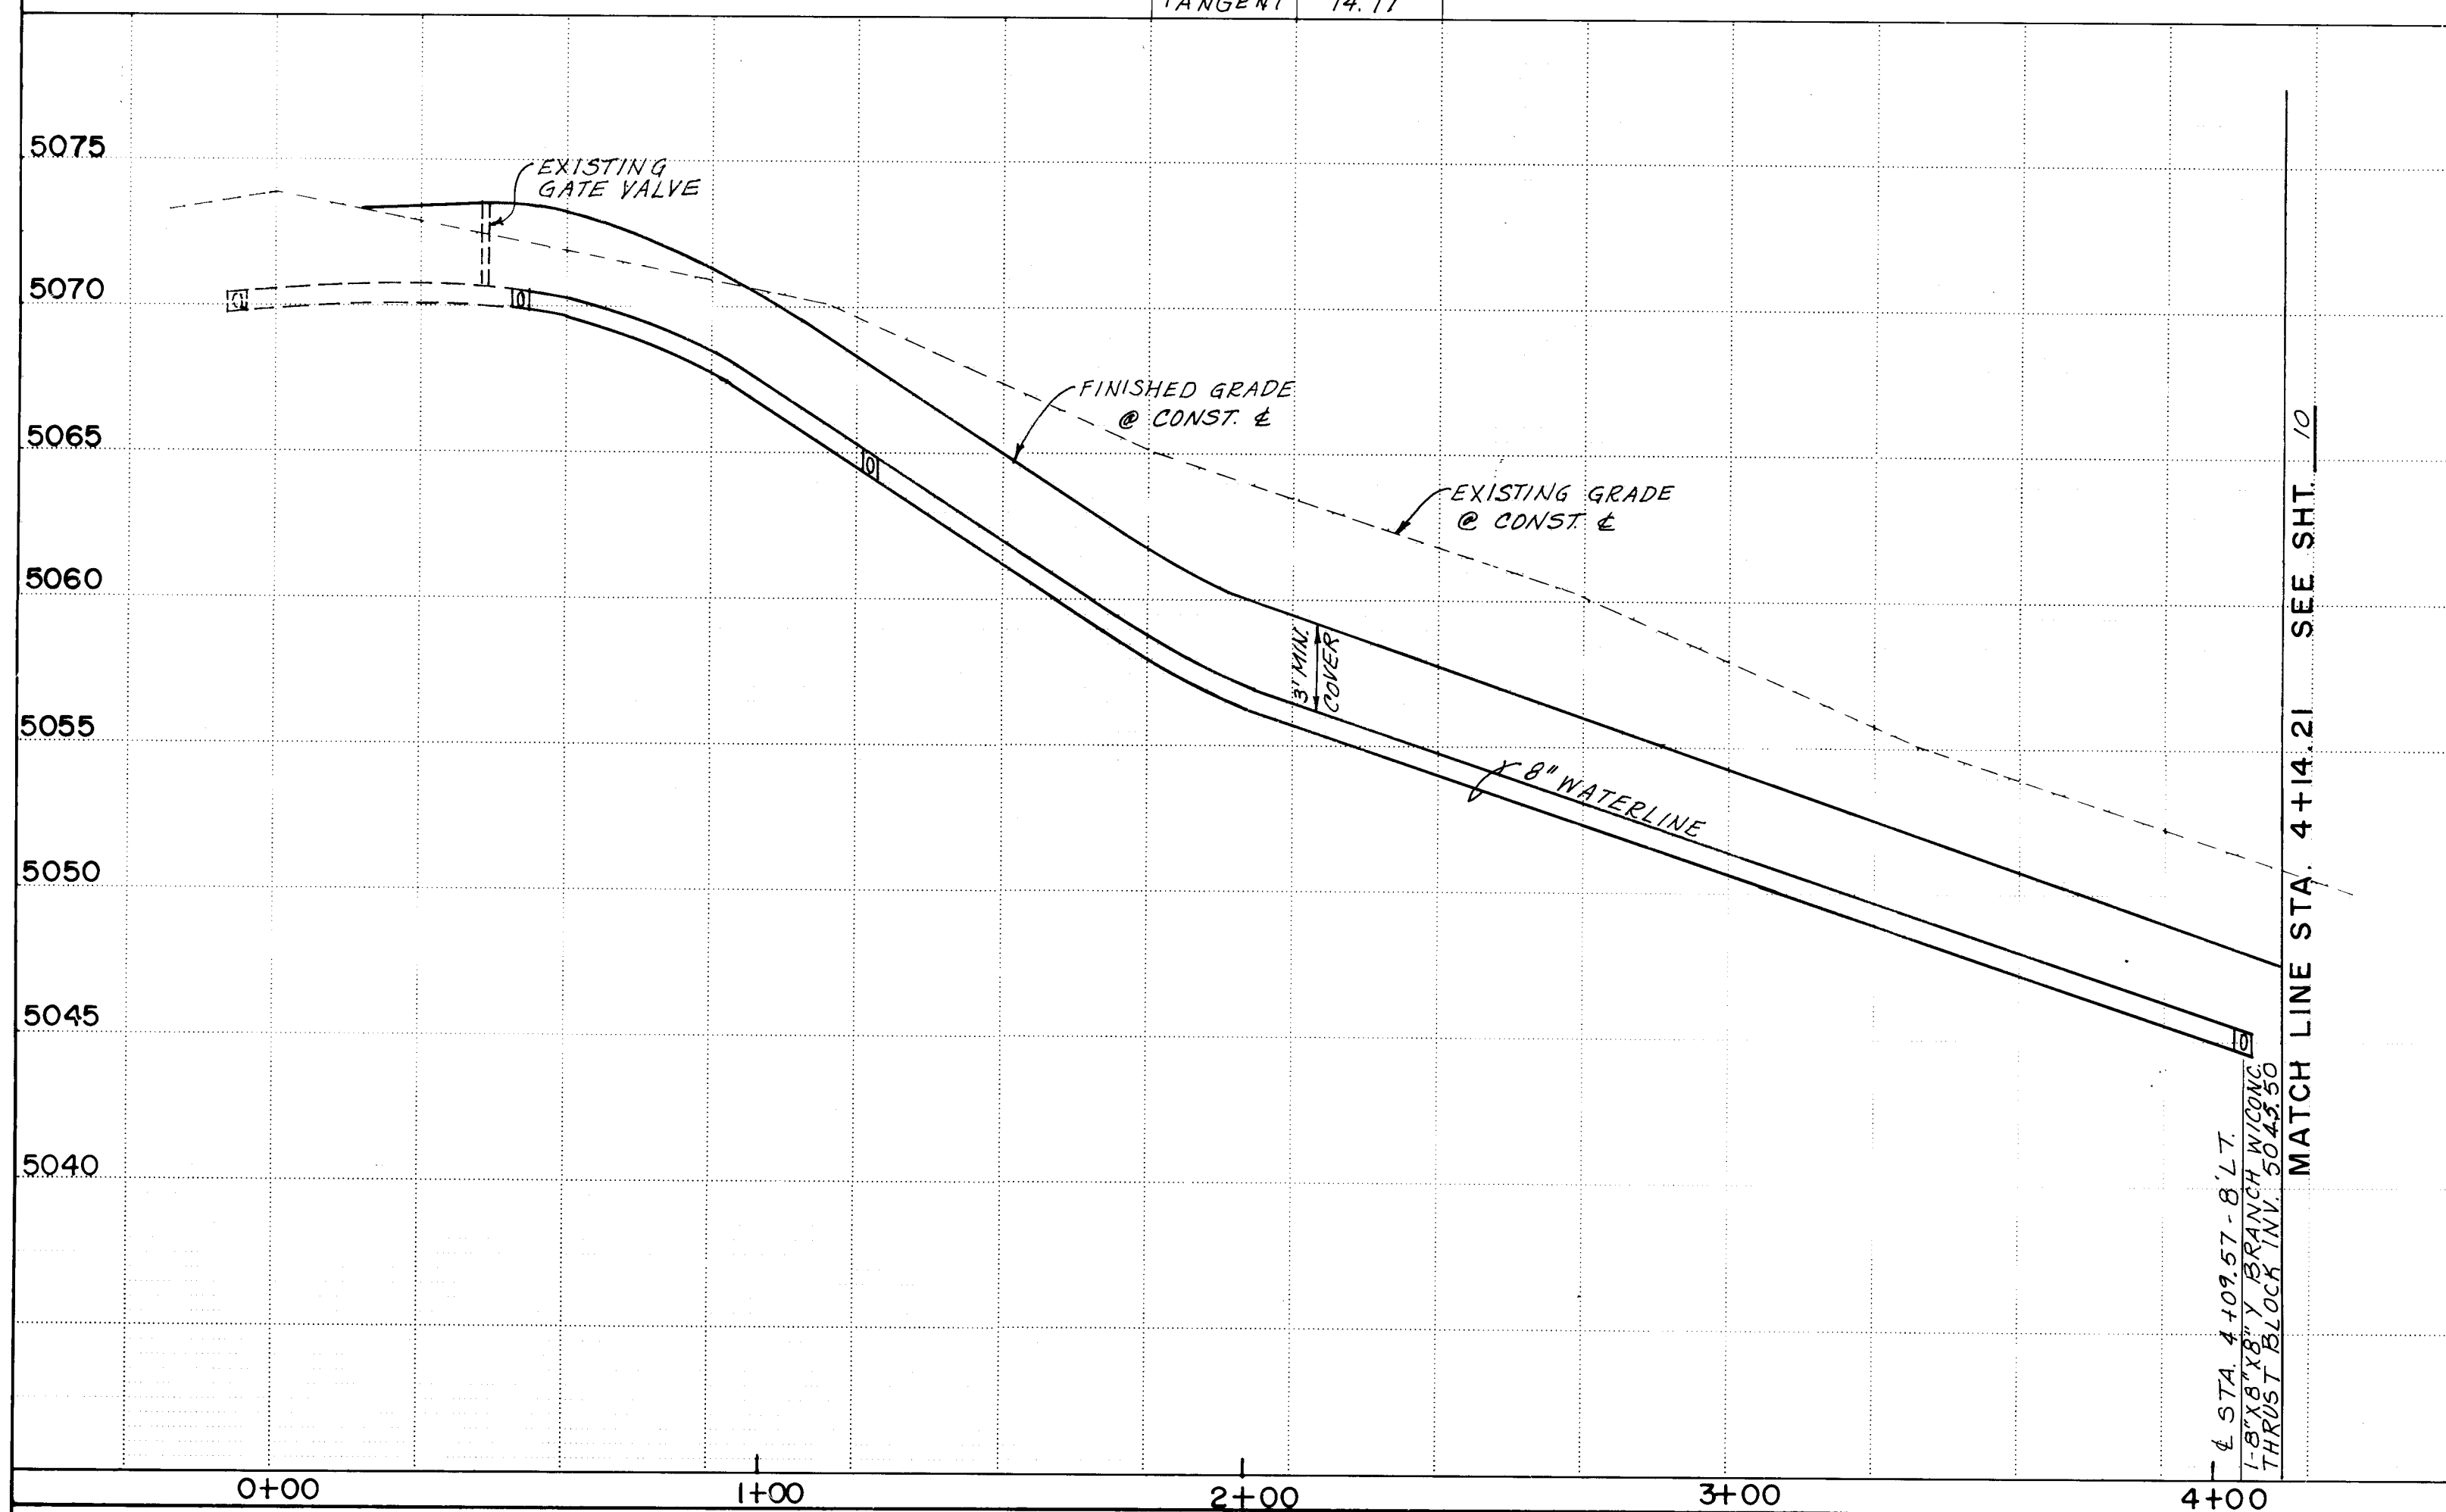

PROPOSED PRIVATE SEWER LINE & M.H. (PER CITY STD. DWG. S-2, S-5)	-SAS-
UTILITY EASEMENT	
PROP. 6" SAS PRIVATE SERVICE LINE W/CLEANOUT (DETAIL ON SHT.6)	
EXIST. TELEPHONE BOX	□
EXIST. GAS REGULATOR	
EXIST. GAS	-G-
EXIST. WATER & VALVE	-W-W-
EXIST. SANITARY SEWER & MANHOLE	-SAS-
EXIST. STORM DRAIN & MANHOLE	-SD-
EXIST. UNDERGROUND ELECTRIC	UE
EXIST. UNDERGROUND TELEPHONE	UT
EXIST. UNDERGROUND CABLE TV	CT
EXIST. CABLE TV BOX	□ C.T.
EXIST. FENCE	-X-X-
EXIST. RIGHT OF WAY	R/W
EXIST. POWER POLE	
PROP. WATER LINE	-W-
PROP. WATER VALVE	
PROP. FIRE HYDRANT (PER STD. DWG. N-10, N-23)	
PROP. WATER METER (PER STD. DWG. N-11, N-12, N-17, N-19)	
NEW STORM DRAIN	SD
NEW STORM DRAIN MANHOLE	
NEW STORM DRAIN INLET (PER STD. DWG. N-1, N-2, N-5)	J.B.
UNION/JOINT BOX	J.B.
REINF. CONCRETE PIPE	R.C.P.
HIGH PRESSURE GAS LINE	H.P.
VERY HIGH PRESSURE GAS LINE	V.H.P.
TOP OF DRIVEPAD	T.D.P.
FINISHED FLOOR	F.F.
DRIVE WAY	D.W.
TOP OF GRATE	T.G.
TOP OF CURB	T.C.
TOP OF SIDEWALK	T.S.
FLOW LINE	FL
CAST IRON PIPE	C.I.P.
CLEANOUT	C.O.

ENGINEER'S SEAL		SURVEY INFORMATION		BENCH MARKS		AS BUILT INFORMATION	
NO.	DATE	REMARKS	FIELD NOTES		DATE	WORK BY	DATE
			BY				
						CONTRACTOR C.C.M.	
						WORK BY: ESPREY HUSTON	DATE: 6/86
						INSPECTORS	
						ACCEPTANCE BY: G.M.A.	DATE: 11/78
						FIELD LOCATION BY: G.M.A.	DATE: 6/86
						DRAWINGS	DATE: 6/86
						CONNECTED BY: E.H.A.	DATE: 6/86
						MICRO-FILM INFORMATION	
						RECORDED BY	DATE
						NO	

CITY OF ALBUQUERQUE MUNICIPAL DEVELOPMENT DEPARTMENT ENGINEERING DIVISION					
TITLE: SOMBRA DEL OSO APARTMENTS AISLE "E" & AISLE "I" UTILITIES PLAN & PROFILE					
APPROVALS	ENGINEER	DATE	APPROVALS	ENGINEER	DATE
City Engineer	<i>[Signature]</i>	3/11/06	Liquid Waste	N/A <i>BR</i>	2-13-06
A.C.E. - Design	<i>[Signature]</i>	3/11/06	Traffic	N/A <i>BR</i>	2/12/06
A.C.E. - Hydrology	<i>[Signature]</i>	3/11/06	Water	<i>B Ryck</i>	2-13-06



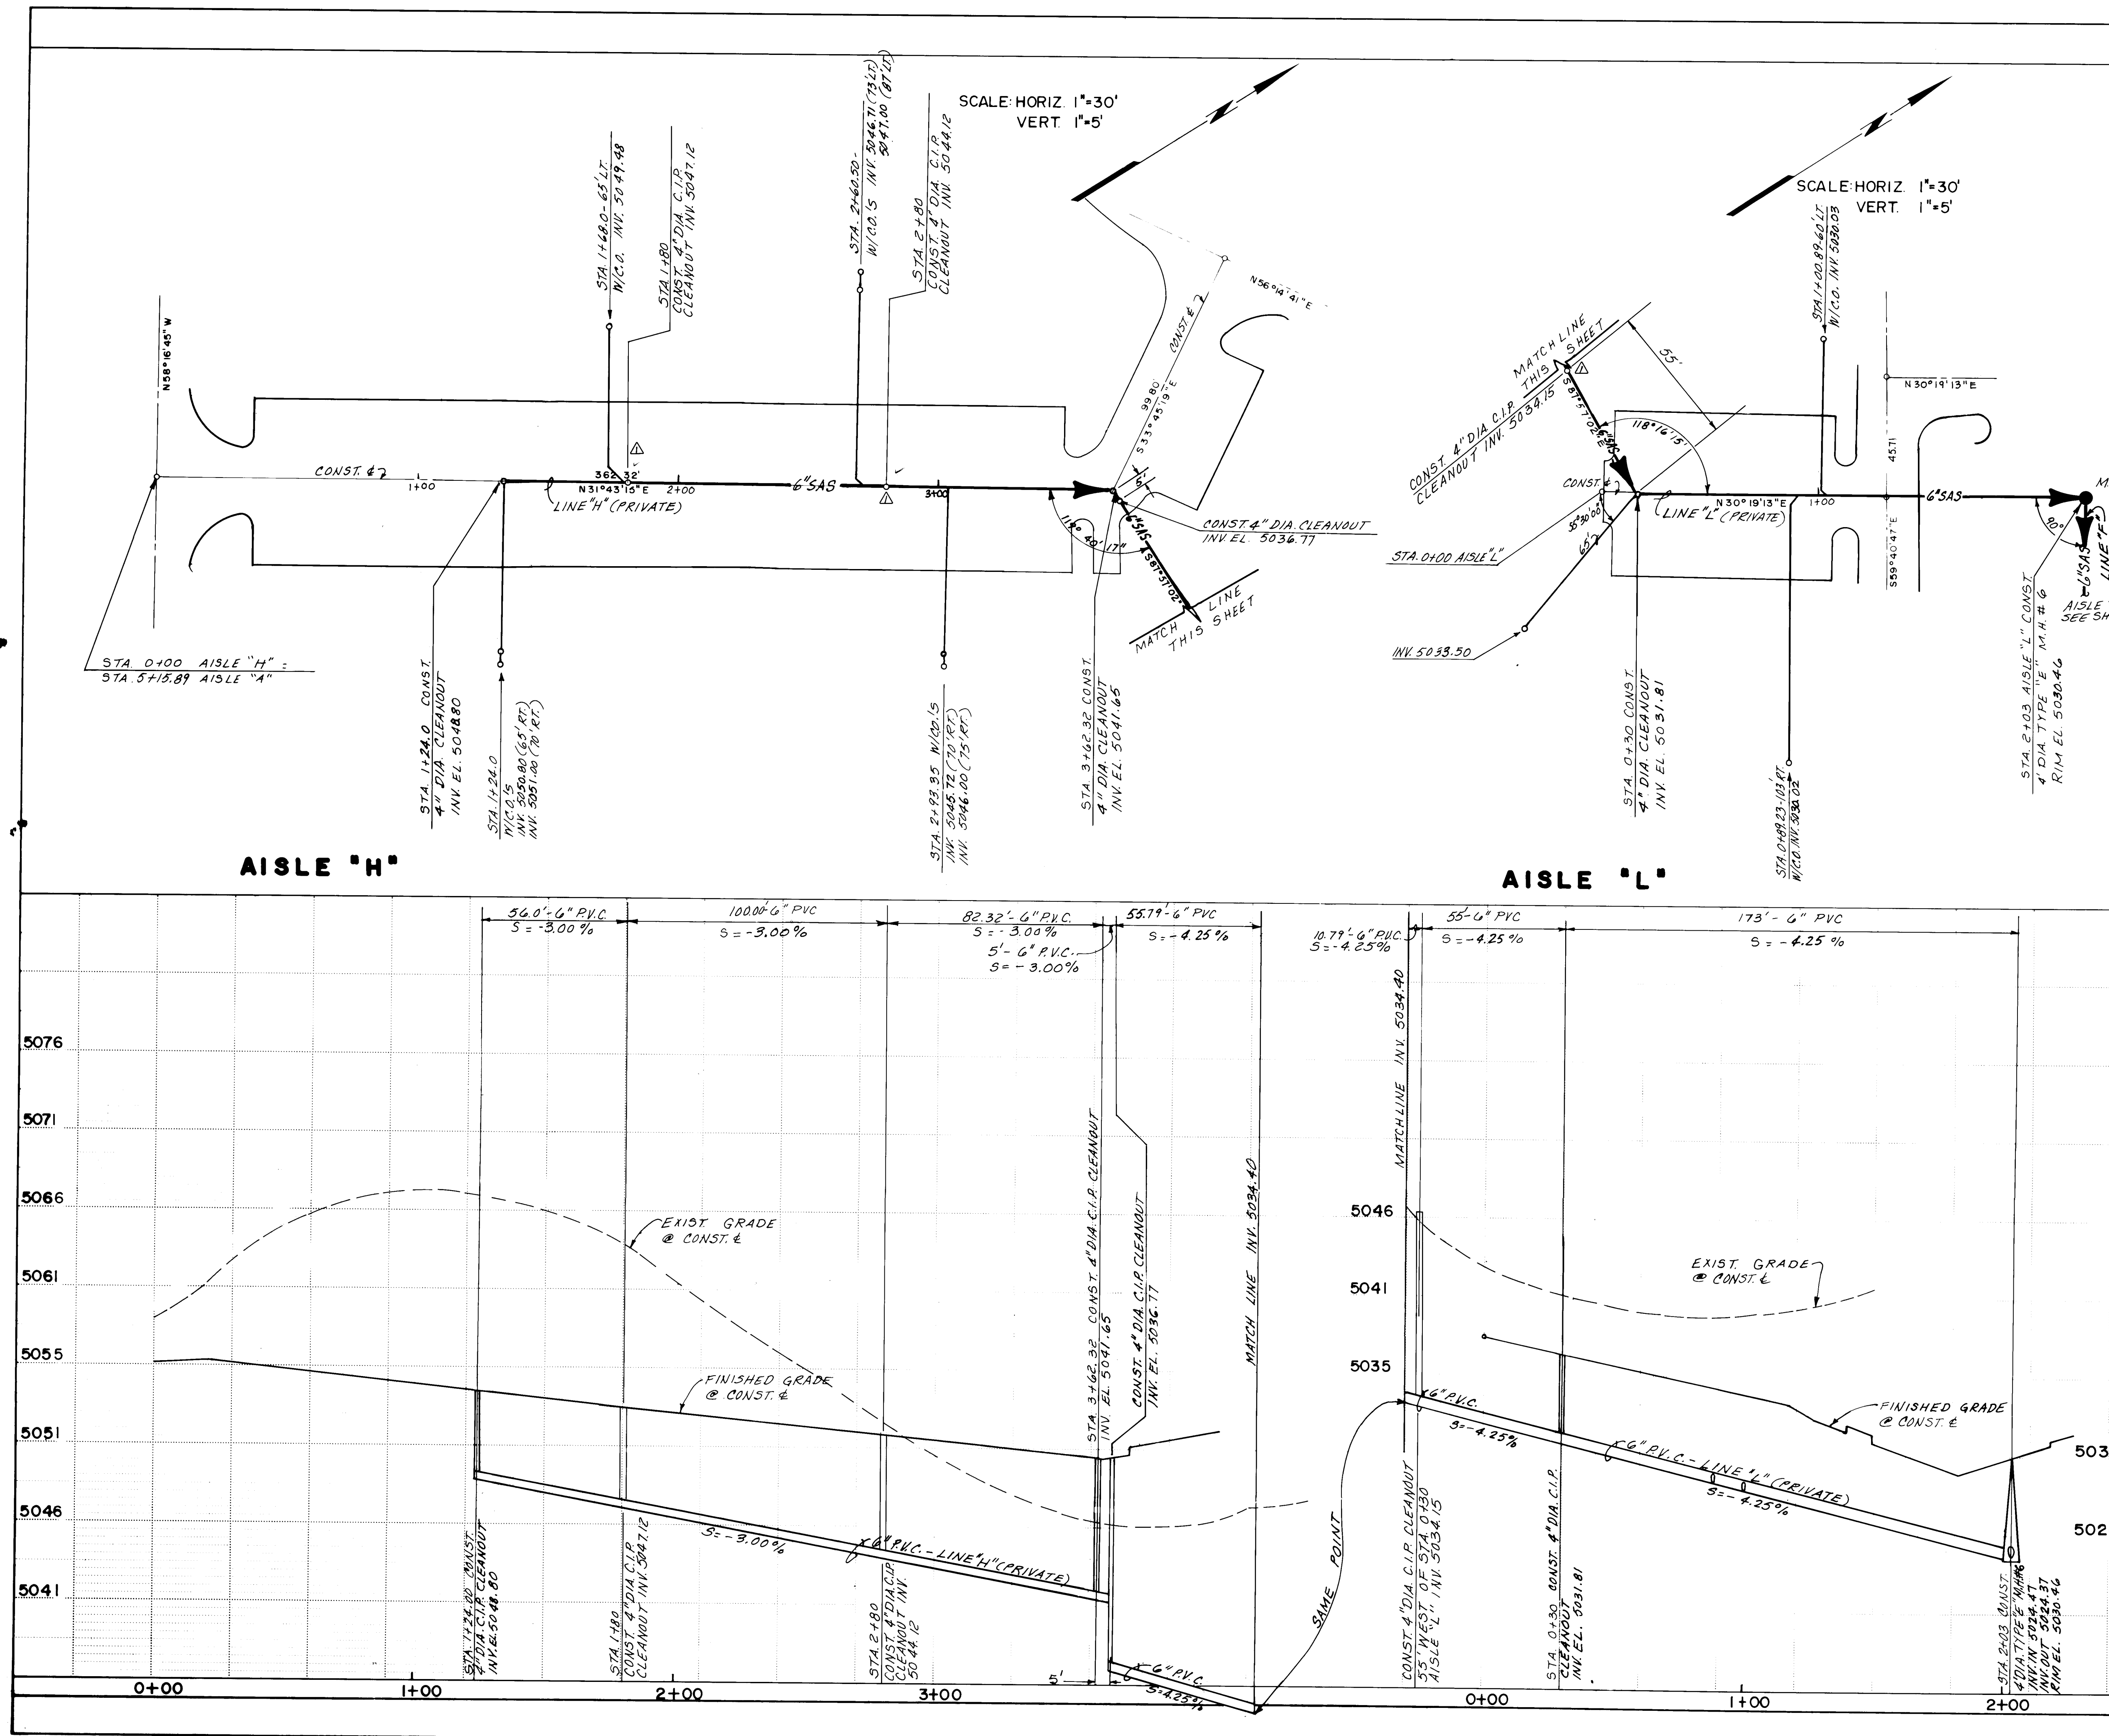


AS BUILT INFORMATION		BENCH MARKS		SURVEY INFORMATION		ENGINEER'S SEAL	
CONTRACTOR C.C.M.		2 M. - N.W. COR. SEC. 26, T.11N, R.2E, N.M.P.M. BRASS		DATE		BY	
WORK BY: ESPY HUSTON		CAP FOUND IN PLACE, NEW MEXICO STATE PLANE		NO.		NO.	
DATE: 6/86		COORDINATE SYSTEM (CENTRAL ZONE)		DATE		DATE	
INSPECTORS: DATE: 6/86		X = 367,164.77 Y = 1,513,731.57 ELEV = 5112.53'		NO.		NO.	
ACCEPTANCE BY G.M.A. DATE: 6/86		T.B.M. - SET @ 11.5' BACK OF CURB @ N.E. COR. OF INTERSECTION OF MONTANA RD. & MONTANA		DATE		DATE	
VERIFICATION BY G.M.A. DATE: 6/86		PLAZA DR. N.W. ELEV. 5071.73'		NO.		NO.	
DRAWING BY: DATE: 6/86		MICRO-FILM INFORMATION		NO.		NO.	
RECORDED BY: DATE: 6/86		NO.		NO.		NO.	

REVISIONS		DESIGN	
NO.	DATE	REMARKS	DATE
1	3/11/86	ADDED CLEANOUTS @ STA. H80, BG	11-27-85
2	3/11/86	2.18M E.S. WEST OF STA. 0+30	12-2-85
3	3/11/86	ADJUSTED PARKING	
4	3/11/86	LOTS & DELETED ISLANDS	

CITY OF ALBUQUERQUE MUNICIPAL DEVELOPMENT DEPARTMENT ENGINEERING DIVISION			
TITLE: SOMBRA DEL OSO APARTMENTS AISLE "H" & AISLE "L" UTILITIES PLAN & PROFILE			
APPROVALS	ENGINEER	DATE	APPROVALS
City Engineer	[Signature]	3/11/86	Liquid Waste
A.C.E. - Design	[Signature]	3/11/86	Traffic
A.C.E. - Hydrology	[Signature]	3/11/86	Water
			N/A GR
			2/2/86
			2/2/86

DRAWING NO. 2745		MAP NO. E-12-Z		SHEET 13 OF 15	
------------------	--	----------------	--	----------------	--

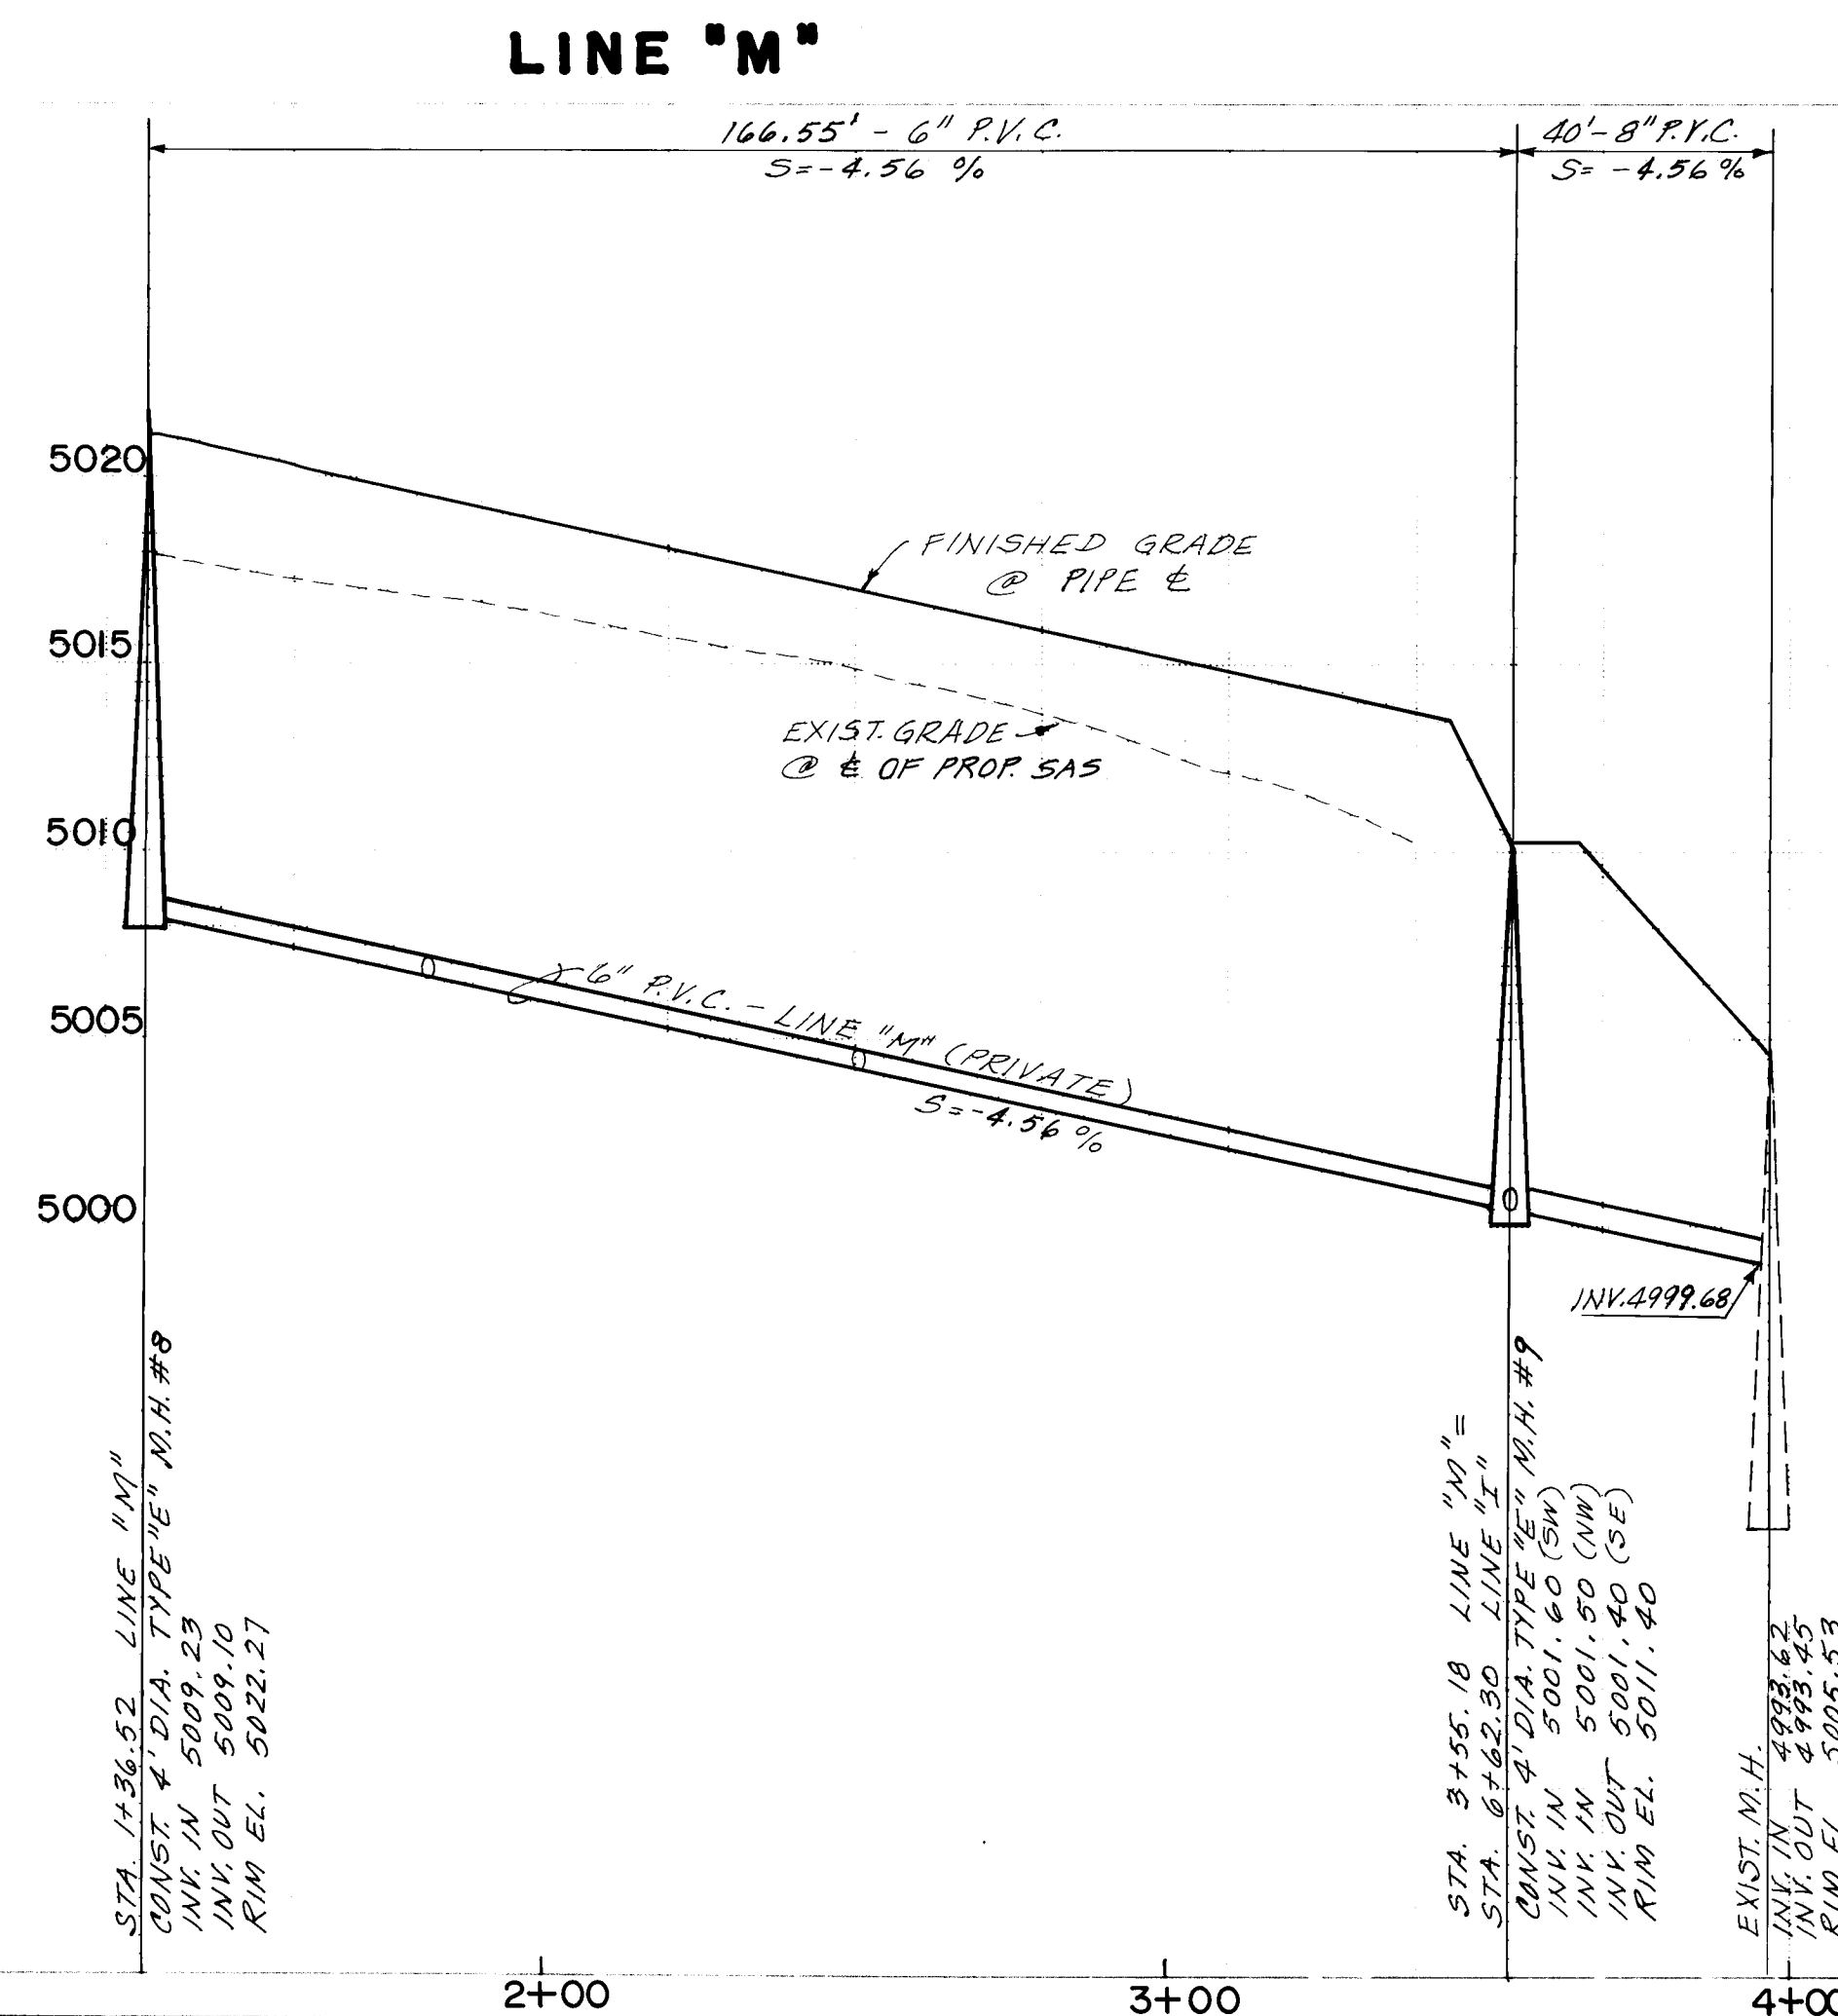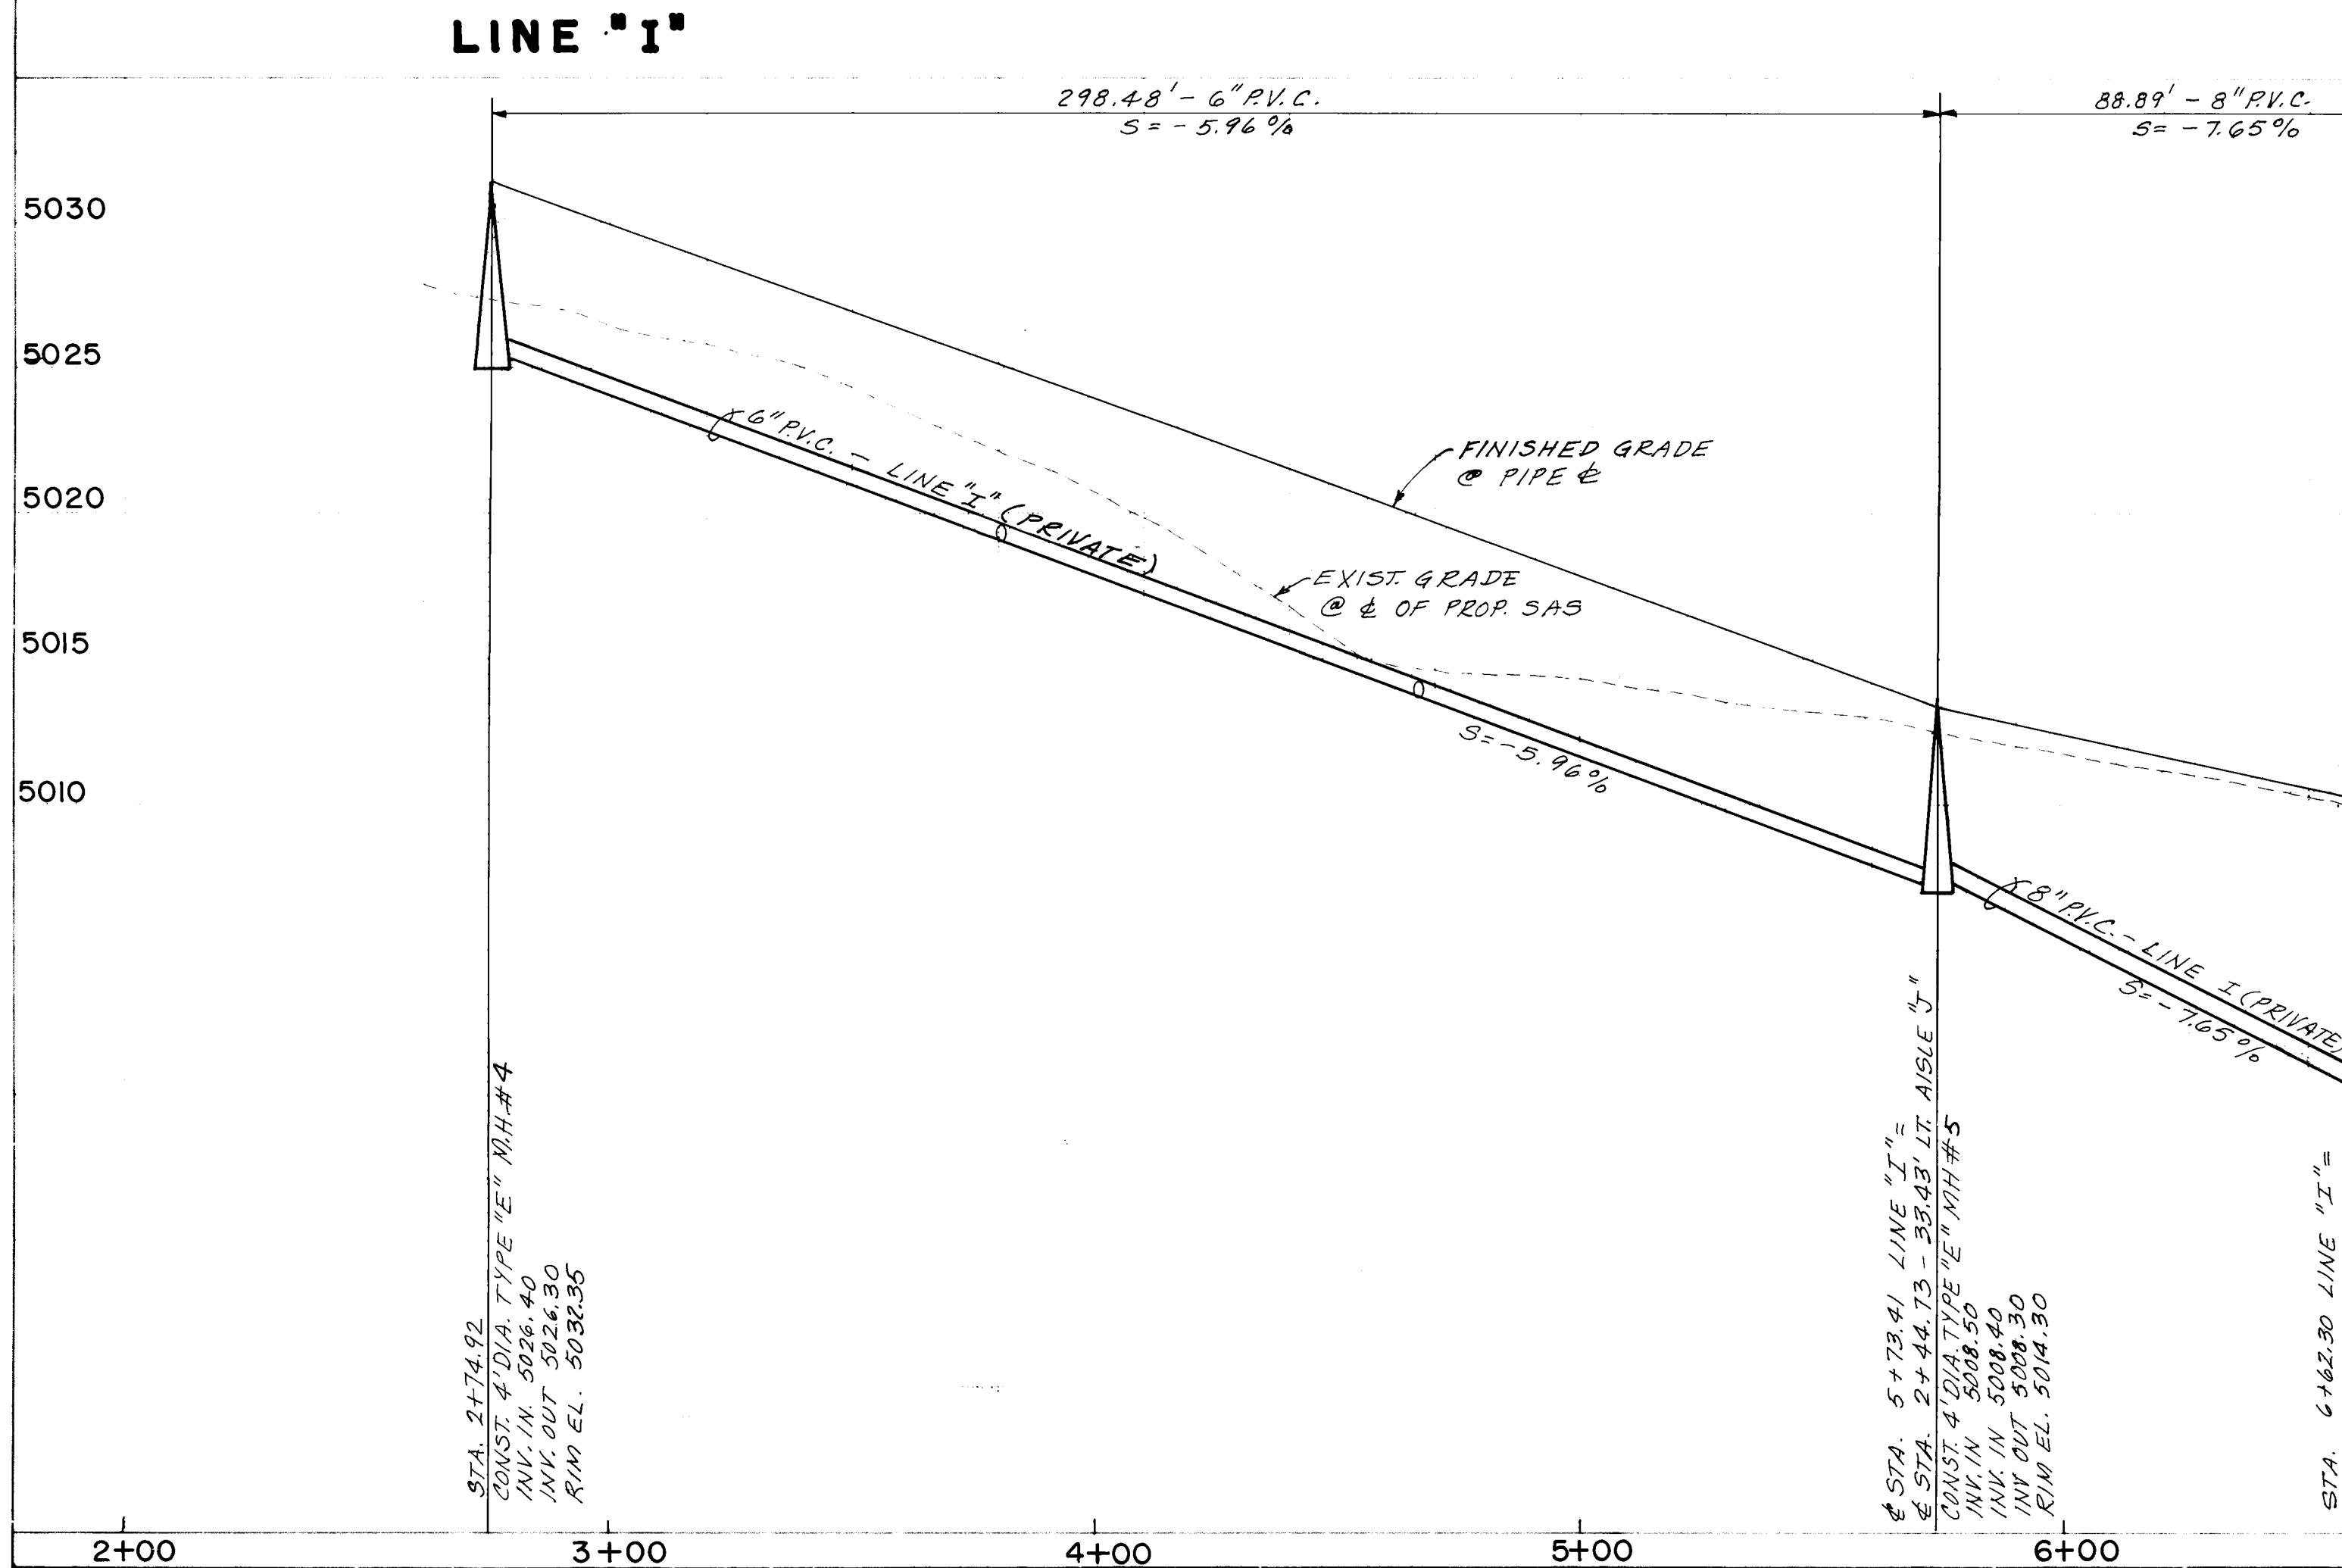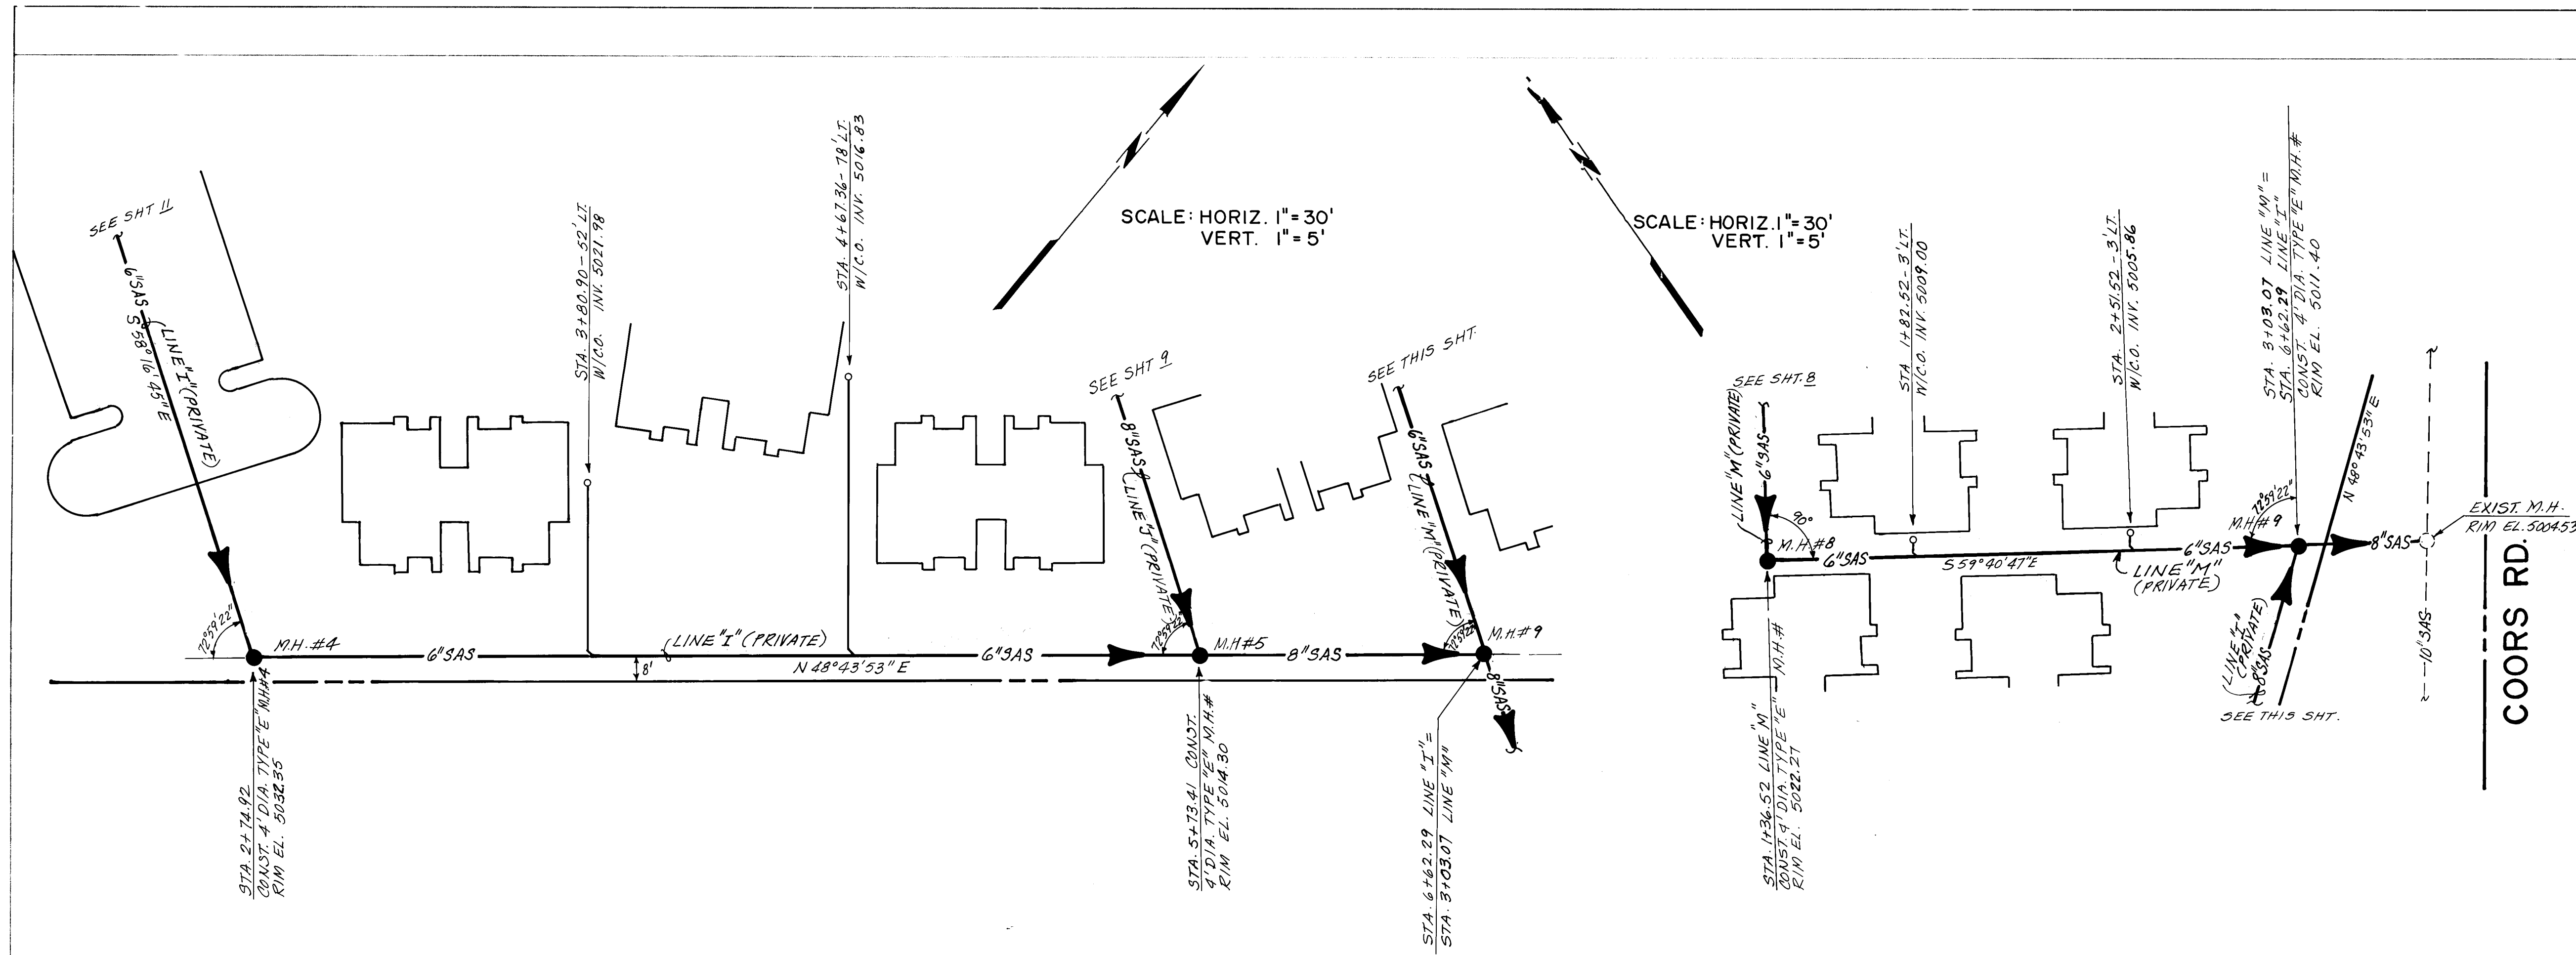

LEGEND


PROPOSED PRIVATE SEWER LINE & M.H. (PER CITY STD. DWG. S-2, S-5)	— SAS —
UTILITY EASEMENT	— U —
PROP. 6" SAS PRIVATE SERVICE LINE W/CLEANOUT (DETAIL ON SHT. 6)	— 6" SAS —
EXIST. TELEPHONE BOX	— T —
EXIST. GAS REGULATOR	— G —
EXIST. GAS	— G —
EXIST. WATER & VALVE	— W —
EXIST. SANITARY SEWER & MANHOLE	— SAS —
EXIST. STORM DRAIN & MANHOLE	— SD —
EXIST. UNDERGROUND ELECTRIC	— UE —
EXIST. UNDERGROUND TELEPHONE	— UT —
EXIST. UNDERGROUND CABLE TV	— CT —
EXIST. CABLE TV BOX	— C.T. —
EXIST. FENCE	— F —
EXIST. RIGHT OF WAY	— R/W —
EXIST. POWER POLE	— P.P. —
PROP. WATER LINE	— W —
PROP. WATER VALVE	— W.V. —
PROP. FIRE HYDRANT (PER STD. DWG. N-20, N-23)	— F.H. —
PROP. WATER METER (PER STD. DWG. N-10, N-12, N-17, N-19)	— W.M. —
NEW STORM DRAIN	— SD —
NEW STORM DRAIN MANHOLE	— S.D.M. —
NEW STORM DRAIN INLET (PER STD. DWG. K-1, K-2, K-5)	— S.D.I. —
JUNCTION BOX	— J.B. —
REINF. CONCRETE PIPE	— R.C.P. —
HIGH PRESSURE GAS LINE	— H.P. —
VERY HIGH PRESSURE GAS LINE	— V.H.P. —
TOP OF DRIVEPAD	— T.D.P. —
FINISHED FLOOR	— F.F. —
DRIVE WAY	— D.W. —
TOP OF GRATE	— T.G. —
TOP OF CURB	— T.C. —
TOP OF SIDEWALK	— T.S. —
FLOW LINE	— F.L. —
CAST IRON PIPE	— C.I.P. —
CLEANOUT	— C.O. —

CITY OF ALBUQUERQUE
MUNICIPAL DEVELOPMENT DEPARTMENT
ENGINEERING DIVISION

TITLE: SOMBRA DEL OSO APARTMENTS
LINES "I" & "M"
UTILITIES PLAN & PROFILE


APPROVALS	ENGINEER	DATE	APPROVALS	ENGINEER	DATE
City Engineer	<i>[Signature]</i>	3/11/86	Liquid Waste	N/A BR	2-13-86
A.C.E. Design	<i>[Signature]</i>	3/11/86	Traffic	N/A DAP	2/11/86
A.C.E. Hydrology	<i>[Signature]</i>	3/11/86	Water	N/A BR	2-13-86

DRAWING NO. **2745** MAP NO. **E-12-Z** SHEET **14** OF **15**

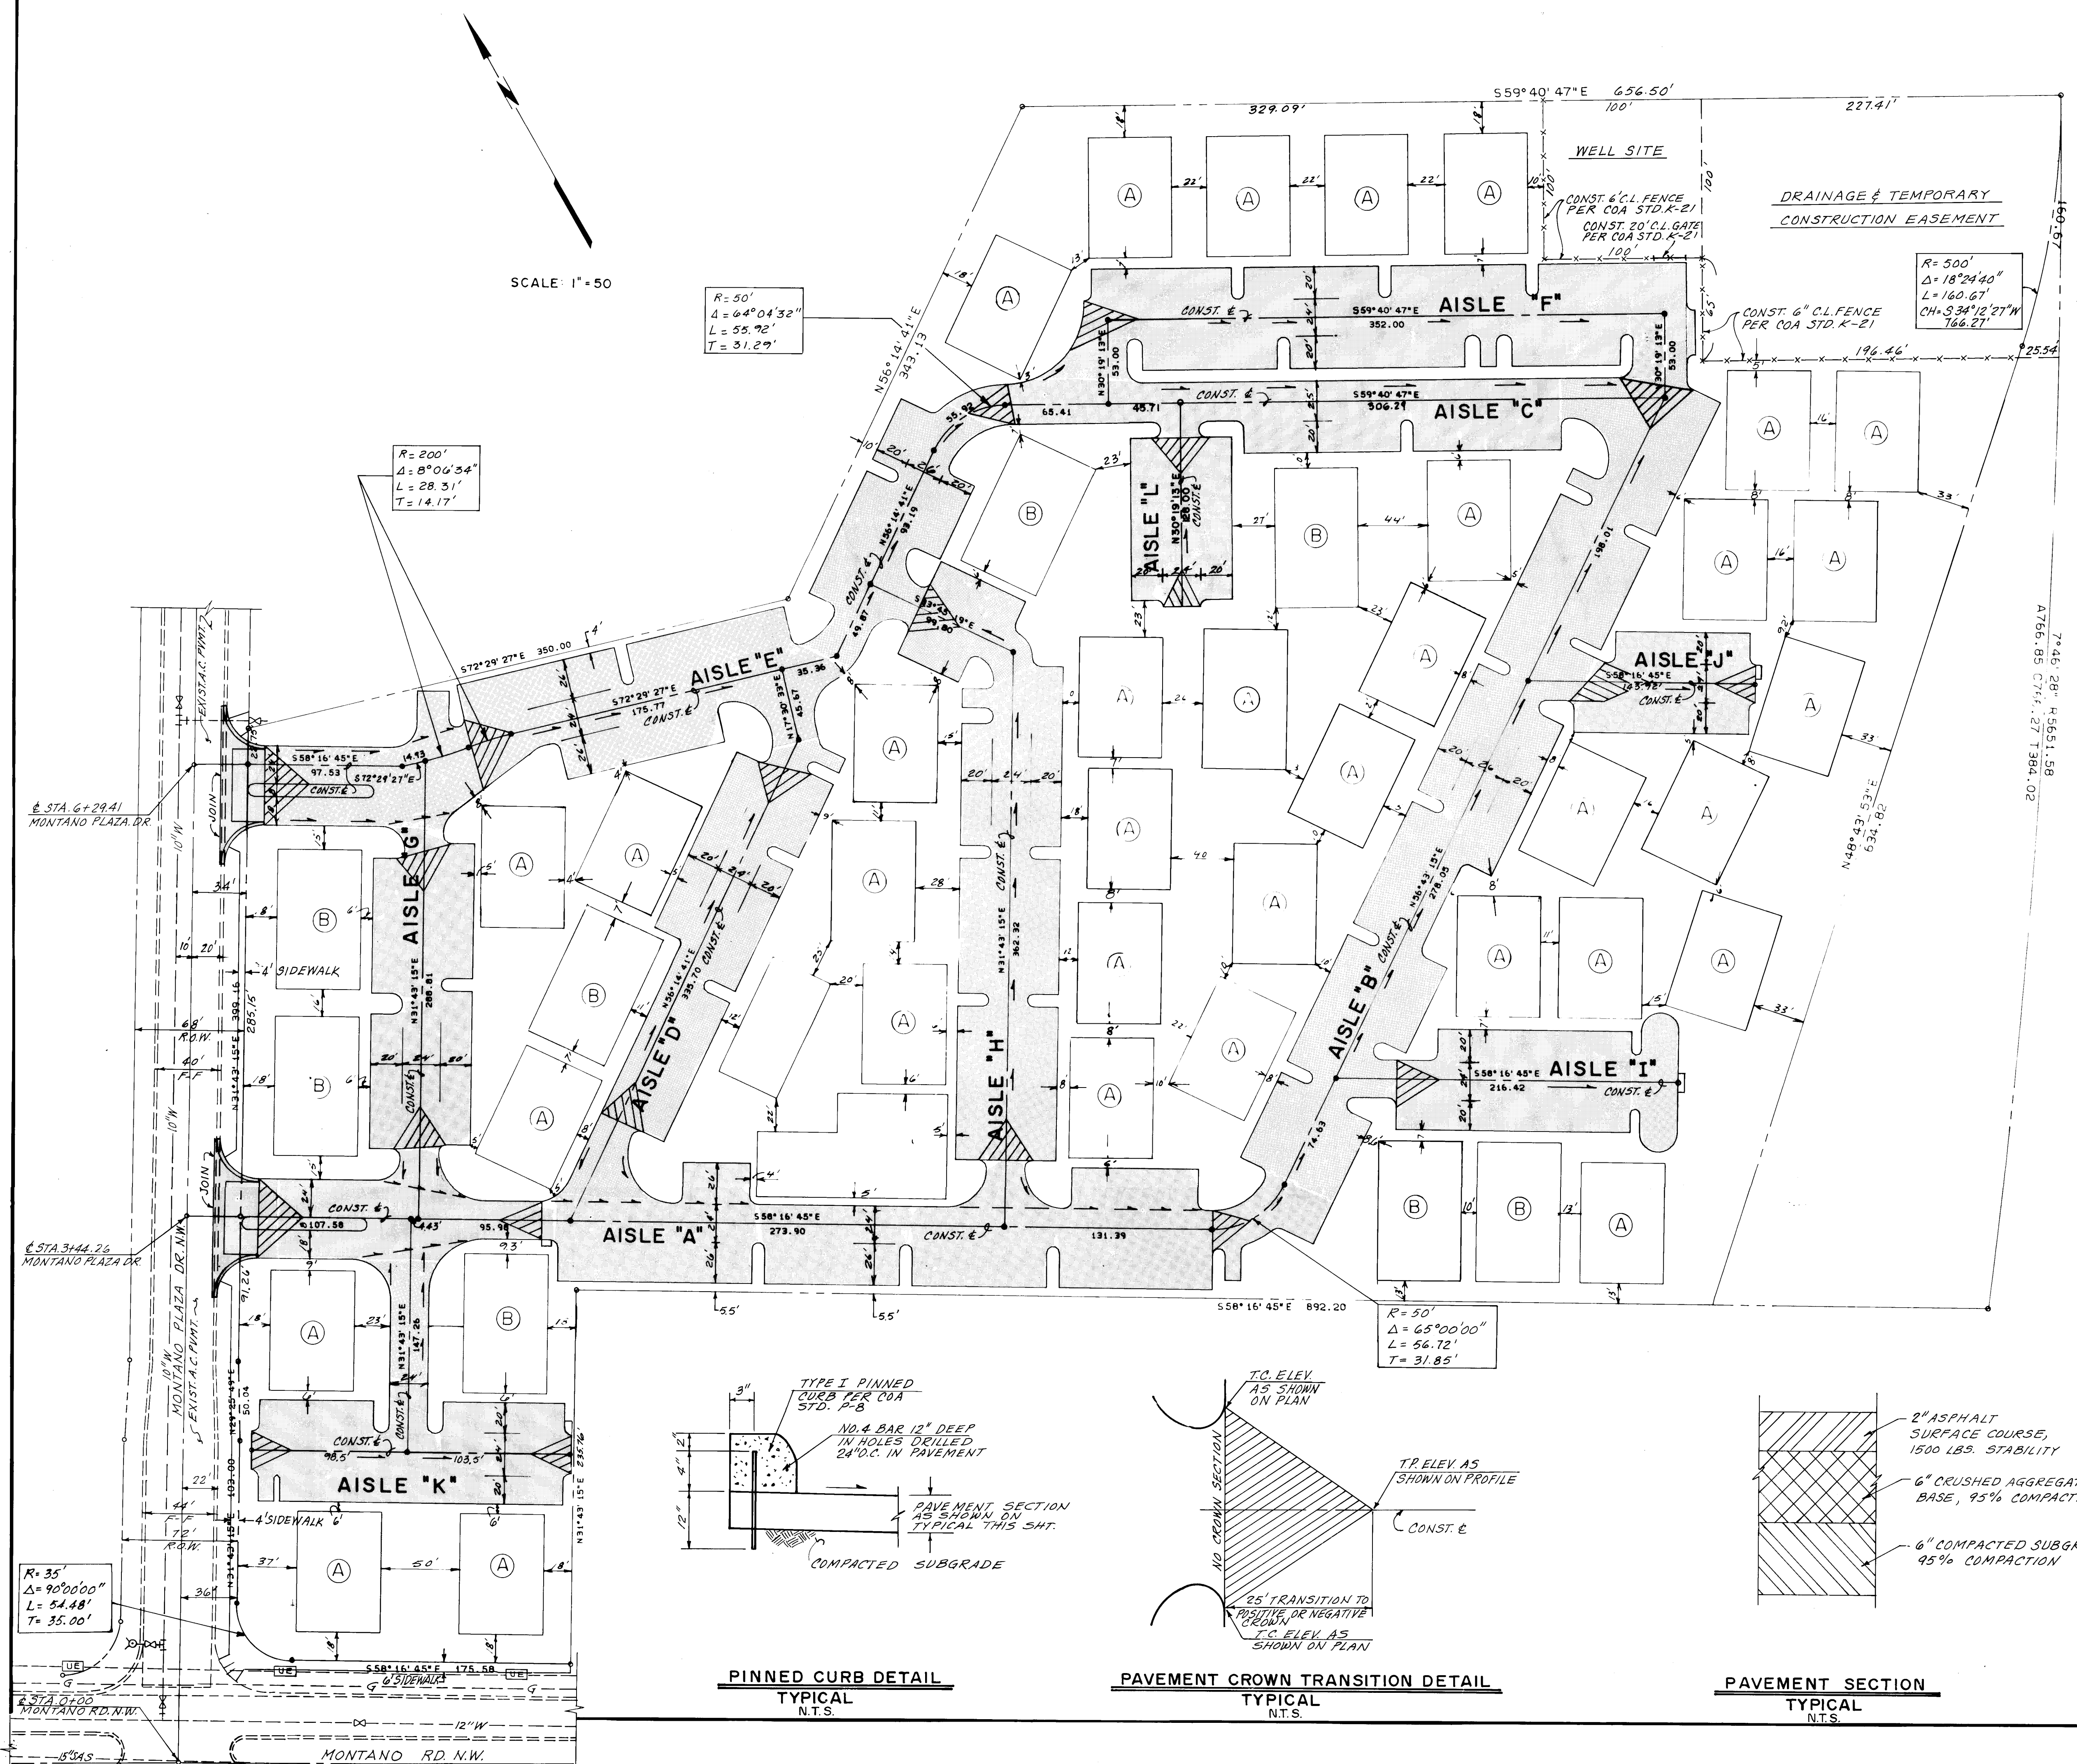


- LEGEND**
- Exist. Curb & Gutter (C. & G.) & sidewalk
 - Proposed Curb & Gutter (C. & G.) & sidewalk
 - Proposed Curb
 - Proposed C. & G.
 - Proposed Wheel Chair Ramp
 - Pavement Crown Transition Area
 - A.P. Angle Point
 - H.P. High Point
 - P.R.C. Point of Reverse Curve
 - P.C.C. Point of Compound Curve
 - T.P. Top of Pavement
 - C.F. Curb Face
 - P.C. Point of Curvature
 - P.T. Point of Tangent
 - P.V.C. Point of Vertical Curve
 - P.V.I. Point of Vertical Intersection
 - P.V.T. Point of Vertical Tangent
 - P.R.V.C. Point of Reverse Vertical Curve
 - R.P. Radial Point
 - Flow Line
 - Paving Area


- GENERAL NOTES:**
- All existing pavement removals shall be conducted by sawcutting along a straight line to a minimum depth of 2".
 - Tack coat requirement shall be determined by the Engineer.
 - A disposal site for all excess excavation material, waste material, removals for pavement, curb & gutter shall be obtained by the Contractor.
 - Backfill compaction to be according to specified street use.
 - Unless otherwise specified, all curb returns shall be straight grade between point of curvature to point of tangent.
 - All dimensions, stationing and offsets are referenced to Aisle construction centerline.

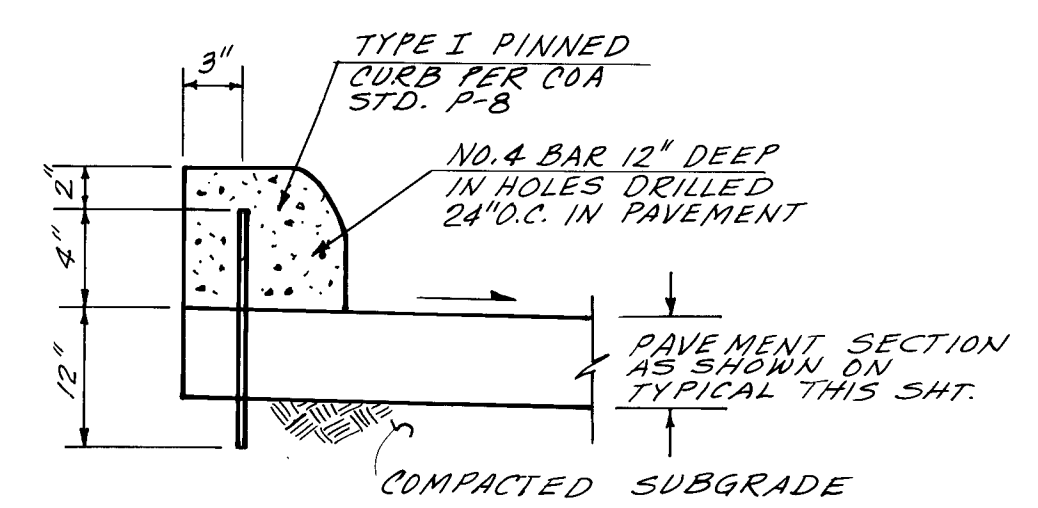

PINNED CURB DETAIL
TYPICAL
N.T.S.

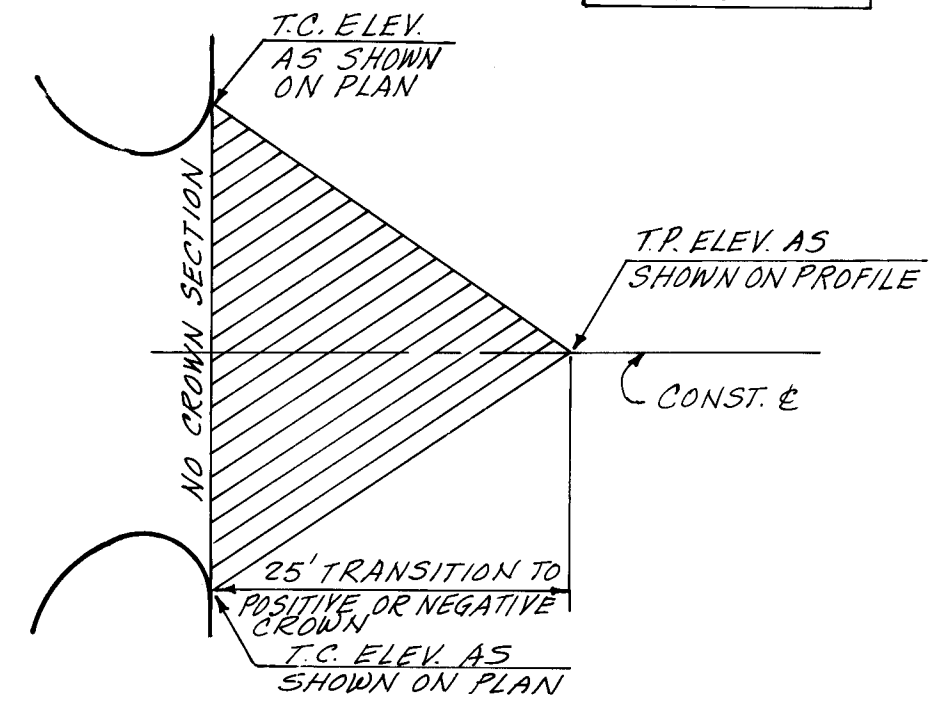

PAVEMENT CROWN TRANSITION DETAIL
TYPICAL
N.T.S.

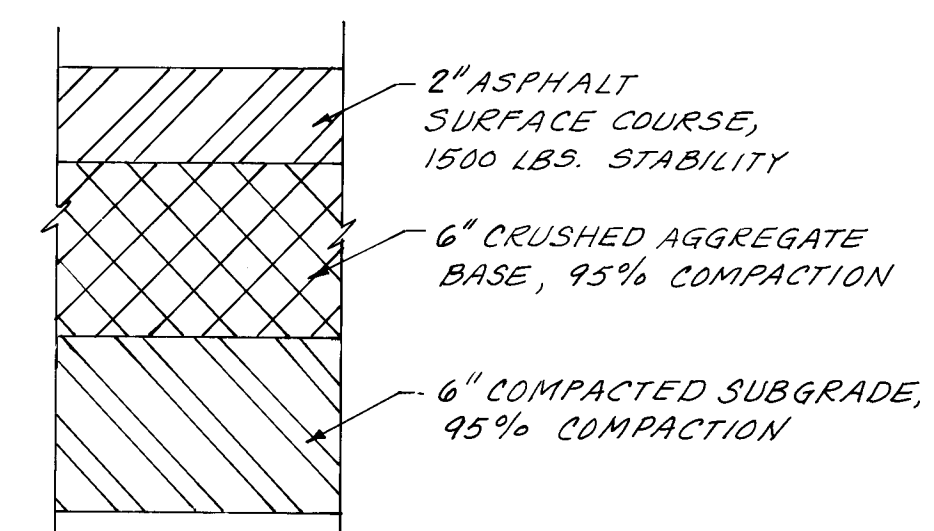

PAVEMENT SECTION
TYPICAL
N.T.S.

FOR INFORMATION ONLY

26 27451588

CITY OF ALBUQUERQUE MUNICIPAL DEVELOPMENT DEPARTMENT ENGINEERING DIVISION			
TITLE SOMBRA DEL OSO APARTMENTS PAVING COMPOSITE			
APPROVALS	ENGINEER	DATE	APPROVALS
City Engineer	ALC	3/1/86	Liquid Waste
A.C.E. - Design	ALC	3/1/86	Traffic
A.C.E. - Hydrology	ALC	3/1/86	Water
DESIGNED BY	R.P.	DATE 12-15-85	ENGINEER
DRAWN BY	M.Y.	DATE 12-16-85	N/A BR
CHECKED BY		DATE	N/A BR
DRAWING NO.	2745	MAP NO.	E-12-Z
		SHEET	15 OF 15

AS BUILT INFORMATION		BENCH MARKS		SURVEY INFORMATION	
CONTRACTOR CCM		CAP FOUND IN PLACE NEW MEXICO STATE PLANE		FIELD NOTES	
WORKED BY: ESPY HUSTON		COORDINATE SYSTEM (CENTRAL ZONE)		NO	
DATE 6/80		X = 361,964.77 Y = 1,513,731.59 ELEV = 5112.53'		BY	
ACCEPTANCE BY G.M.A.		T.B.M. - SET @ 11.5' BACK OF CURB @ N.E. COR. OF INTERSECTION OF MONTANO RD. & MONTANO PLAZA DR. N.W. ELEV. 5071.73'		DATE	
DATE 6/86		DRAWING NO.		NO	
DATE		MICRO-FILM INFORMATION		DATE	
RECORDED BY		NO		DATE	