

**MONTESSA PARK RENOVATION
ENVIRONMENTAL HEALTH
DEPARTMENT**

CITY OF ALBUQUERQUE

PROJECT NO. 2807

METRON ARCHITECTS GROUP
413 MONTCLAIRE DRIVE, N.E.
265-8590

Civil Engineering
Structural Engineering
Mechanical Engineering
Electrical Engineering
Specifications

Hall Engineering Co. Inc.
James Innis, A. E.
Walker Consulting Engineers
John R. Cejka
Gordon E. Bosl A.I.A.

DRAWING INDEX

A-1 SITE PLAN
A-2 SITE PLAN, DETAILS AND CALCULATIONS
A-3 SITE PLAN, LANDSCAPE PLAN, DESIGN CRITERIA
A-4 OFFICE LABORATORY BUILDING: FLOOR PLAN, FOUNDATION PLAN
A-5 OFFICE LABORATORY BUILDING: FOUNDATION DETAILS, BUILDING ELEVATIONS
A-6 OFFICE LABORATORY BUILDING: BUILDING SECTIONS
A-7 OFFICE LABORATORY BUILDING: INTERIOR ELEVATIONS, DOOR, WINDOW AND ROOM FINISH SCHEDULES
A-8 TRUCK SHED: FLOOR PLAN, FOUNDATION PLAN, FOUNDATION DETAILS, WALL SECTION
A-9 TRUCK SHED: BUILDING SECTION, FOUNDATION DETAILS, BUILDING ELEVATIONS
A-10 CAR WASH: FLOOR PLAN, FOUNDATION PLAN, FOUNDATION DETAILS, BUILDING ELEVATIONS
A-11 CAR WASH: SECTION: RETENTION POND: PLAN, SECTION
M-1 UTILITY SITE PLAN
M-2 OFFICE LABORATORY BUILDING: MECHANICAL PLAN, EQUIPMENT SCHEDULE, MECHANICAL NOTES
M-3 OFFICE LABORATORY BUILDING, CAR WASH: WASTE PIPING PLANS; CAR WASH: WATER PIPING PLAN
M-4 OFFICE LABORATORY BUILDING: WATER AND GAS PIPING PLAN, FIXTURE SCHEDULE
E-1 OFFICE LABORATORY BUILDING, CAR WASH, TRUCK SHED: ELECTRICAL PLANS
E-2 ELECTRICAL NOTES, SCHEDULES, POWER RISER DIAGRAM, TELEPHONE RISER DIAGRAM


LOCATION MAP

26 28070188

REV	SHEETS	CITY	ENGR.	DATE	USER	DEPT.	DATE	USER	DEPT.	DATE
APPROVAL OF REVISIONS										
METRON ARCHITECTS GROUP 413 Montclair Drive NE Albuquerque, NM 87108 505 / 265-8590 PROJECT NUMBER 2807 APPROVED FOR CONSTRUCTION <i>[Signature]</i> 1/12/88										


SPECIFIC NOTES - MECHANICAL

1. FR , 10" X 2", 50 CFM.
2. FR , 14" X 2", 100 CFM.
3. FR , 10" X 4", 125 CFM.
4. FR , 12" X 4", 150 CFM.
5. CD , 6" DIA. NECK, 100 CFM, 12" X 12" FACE.
6. CD , 8" DIA. NECK, 300 CFM, 24" X 24" FACE.
7. CD , 8" DIA. NECK, 400 CFM, 24" X 24" FACE.
8. CD , 8" DIA. NECK, 425 CFM, 24" X 24" FACE.
9. CD , 10" DIA. NECK, 500 CFM, 24" X 24" FACE.
10. CD , 10" DIA. NECK, 450 CFM, 24" X 24" FACE.
11. CD , 14" DIA. NECK, 950 CFM, 24" X 24" FACE.
12. 12" X 12" RA IN CEILING.
13. CONCRETE PLENUM BELOW FURNACE, SAME SIZE AS FURNACE OUTLET. RETURN AIR PLENUM UP FROM TOP OF FURNACE INTO CEILING SPACE. SEE INSTALLATION DETAIL.
14. EVAPORATIVE COOLER ON ROOF. SEE INSTALLATION DETAIL.
15. 20" X 20" SUPPLY DUCT DOWN THRU ROOF INTO CEILING SPACE.
16. 4" DIA. EXHAUST DUCT UP THRU ROOF TO WEATHER CAP.
17. COORDINATE UNDERFLOOR DUCTWORK WITH WASTE PIPING.
18. THERMOSTATICALLY CONTROLLED AIR VOLUME DAMPER.
19. DUCT DOWN FROM FAN INLET TO 12" X 12" RA IN CEILING.
20. 16" X 4" COMBUSTION AIR DUCT FROM GOOSENECK ABOVE ROOF DOWN TO 12" AFF.
21. INTERLOCK EXHAUST FAN WITH FURNACE MOTOR.
22. MOUNT EXHAUST FAN ON ROOF AND CONNECT TO EXHAUST HOOD IN ROOM BELOW. EXHAUST FAN TO BE SUPPLIED WITH HOOD. VERIFY ALL CONNECTIONS AND MOUNTING REQUIREMENTS.
23. CONNECT WATER HEATER FLUE AND FURNACE FLUE TO SINGLE 5" DIA. FLUE AND EXTEND THRU ROOF TO WEATHER CAP.
24. MOUNT HUMIDIFIER AT 84" AFF.

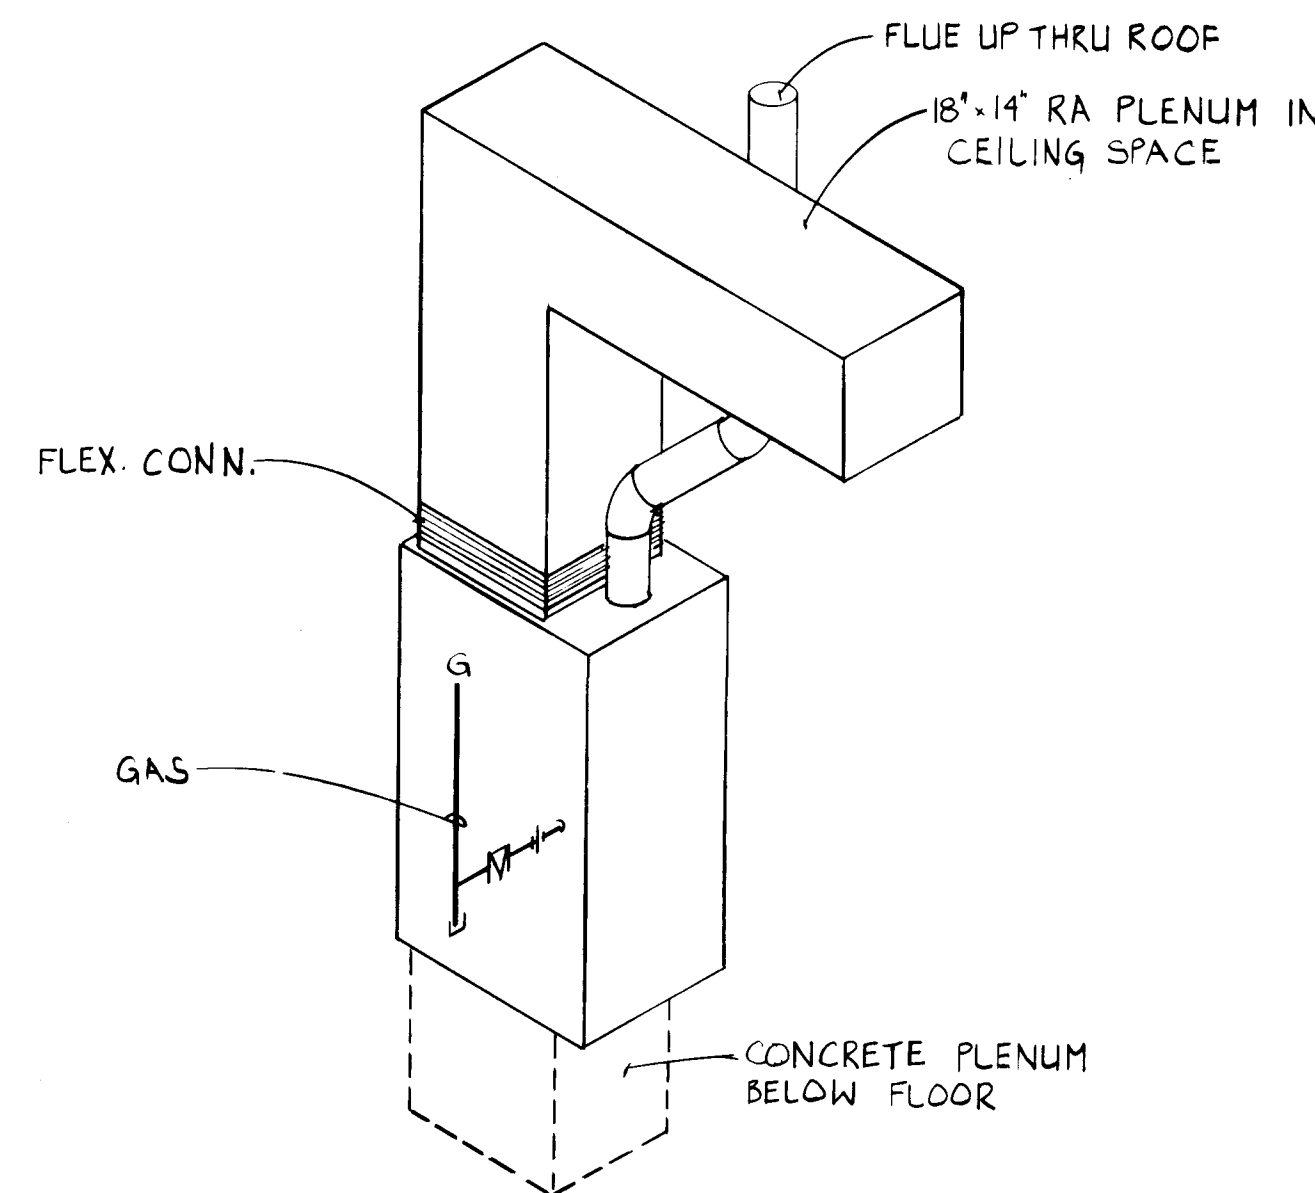

FURNACE INSTALLATION SCHEMATIC
NO SCALE


FURNACE: AGA APPROVED, NATURAL GAS FIRED, DOWN FLOW FURNACE ORFICED FOR 5000' ELEVATION. UNIT SHALL HAVE MULTI-SPEED, DIRECT DRIVE FAN AND SPEED TAP SELECTOR, PRINTED CIRCUIT CONTROL CENTER, SOLID STATE BLOWER CONTROL, CROSS-PORT DESIGN BURNERS FABRICATED FROM ALUMINIZED STEEL, ELECTRIC SPARK PILOT, 115 V - 1 PH ELECTRICAL, LIMIT CONTROLS AND GAS TRAIN, TRANSFORMER, HEATING THERMOSTAT, AND 1" THICK THROUGHWAY FILTERS. MODEL NUMBERS ARE PAYNE.							
<u>SYMBOL</u>	<u>MODEL</u>	<u>CFM</u>	<u>ESP</u>	<u>HP</u>	<u>BTUH INPUT</u>		
(1)	3960048100	1350	.6"	1/2	100,000		
EVAPORATIVE COOLER: DRIP TYPE, SIDE DISCHARGE COOLER WITH PADS, PUMP, FLOAT AND MAKE-UP ASSEMBLY, AND 26 GAUGE GALVANIZED STEEL COVERS. MOTORS SHALL BE TWO SPEED AND THE CAPACITIES ARE CERTIFIED. MODEL NUMBERS ARE MCGRAW-EDISON.							
<u>SYMBOL</u>	<u>MODEL</u>	<u>CFM</u>	<u>ESP</u>	<u>HP</u>	<u>VOLTS</u>	<u>PH</u>	<u>WEIGHT</u>
(2)	ES630	4000	.3"	3/4	115	1	400
EXHAUST FAN: ROOF MOUNTED, DIRECT DRIVEN, CENTRIFUGAL TYPE EXHAUST FAN. PROVIDE WITH BACKDRAFT DAMPER, BIRD SCREEN AND UNIT MOUNTED DISCONNECT SWITCH. MODEL NUMBERS ARE GREENHECK.							
<u>SYMBOL</u>	<u>MODEL NO.</u>	<u>CFM</u>	<u>ESP</u>	<u>VOLTS</u>	<u>PH</u>	<u>HP</u>	
(3)	E-65-D	230	.125	115	1	1/30	
EXHAUST FAN: ROOF MOUNTED, DIRECT DRIVEN, CENTRIFUGAL TYPE EXHAUST FAN WITH NO SPARKING CONSTRUCTION AND EXPLOSION PROOF MOTOR. PROVIDE WITH BACKDRAFT DAMPER, BIRD SCREEN AND UNIT MOUNTED DISCONNECT SWITCH. MODEL NUMBERS ARE GREENHECK.							
<u>SYMBOL</u>	<u>MODEL NO.</u>	<u>CFM</u>	<u>ESP</u>	<u>VOLTS</u>	<u>PH</u>	<u>HP</u>	
(4)	G-75-D	375	.125	115	1	1/25	
HUMIDIFIER: SELF CONTAINED ELECTRODE STEAM HUMIDIFIER. UNIT SHALL HAVE A CAPACITY OF 10 LBS/HR OF STEAM. UNIT SHALL HAVE CONDUCTIVITY SENSOR, WATER LEVEL SENSOR, INTERNAL OVERLOAD PROTECTION, AUTOMATIC CYLINDER FLUSHING, LOCKING STEEL CABINET, AND ROOM DIFFUSION UNIT. THE UNIT SHALL BE PROVIDED WITH L.E.D. DISPLAYS TO INDICATE THE FOLLOWING: PERCENT OF SET POINT, FILL, DRAIN AND CYLINDER FULL, AND FAULT. ELECTRICAL - 220 V - 1 PH, 3.3 KW. HERRMIDIFIER MODEL EST 220110.							
<u>SYMBOL</u>	<u>MODEL NO.</u>	<u>CFM</u>	<u>ESP</u>	<u>VOLTS</u>	<u>PH</u>	<u>HP</u>	
(5)	SP-8	90	.125	120	1	1/125	
EXHAUST FAN: CEILING MOUNTED, DIRECT DRIVE, CENTRIFUGAL TYPE EXHAUST FAN WITH 1/2" ACOUSTICAL LINER, BACKDRAFT DAMPER AND ALUMINUM INLET GRILLE. MODEL NUMBERS ARE GREENHECK.							
<u>SYMBOL</u>	<u>MODEL NO.</u>	<u>CFM</u>	<u>ESP</u>	<u>VOLTS</u>	<u>PH</u>	<u>HP</u>	
(6)	SP-8	90	.125	120	1	1/125	
ELECTRIC BASEBOARD HEATER: SEE ELECTRICAL PLANS							
EXHAUST FAN: SUPPLIED WITH LABORATORY HOOD.							
CD CEILING DIFFUSER: KRUEGER 1400 SERIES WITH OBD, STEEL CONSTRUCTION AND OFF-WHITE FINISH.							
RA RETURN AIR GRILLE: KRUEGER EGC-5, WITH OFF-WHITE FINISH.							
FR FLOOR REGISTER: KRUEGER 700 SERIES WITH OBD AND FACTORY BAKED BROWN FINISH.							

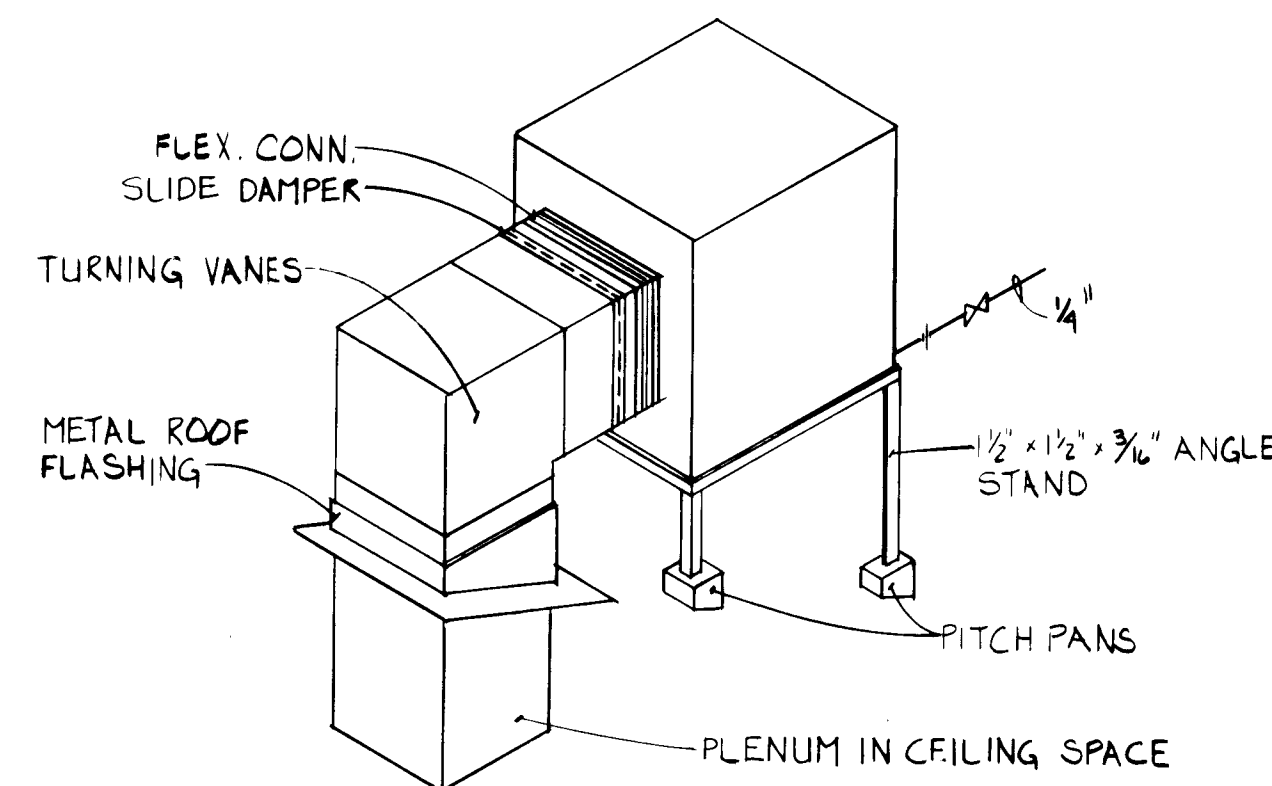

COOLER INSTALLATION SCHEMATIC
NO SCALE

LEGEND

- UNDERFLOOR DUCT
- ABOVE GROUND DUCT
- ROOFTOP EQUIPMENT

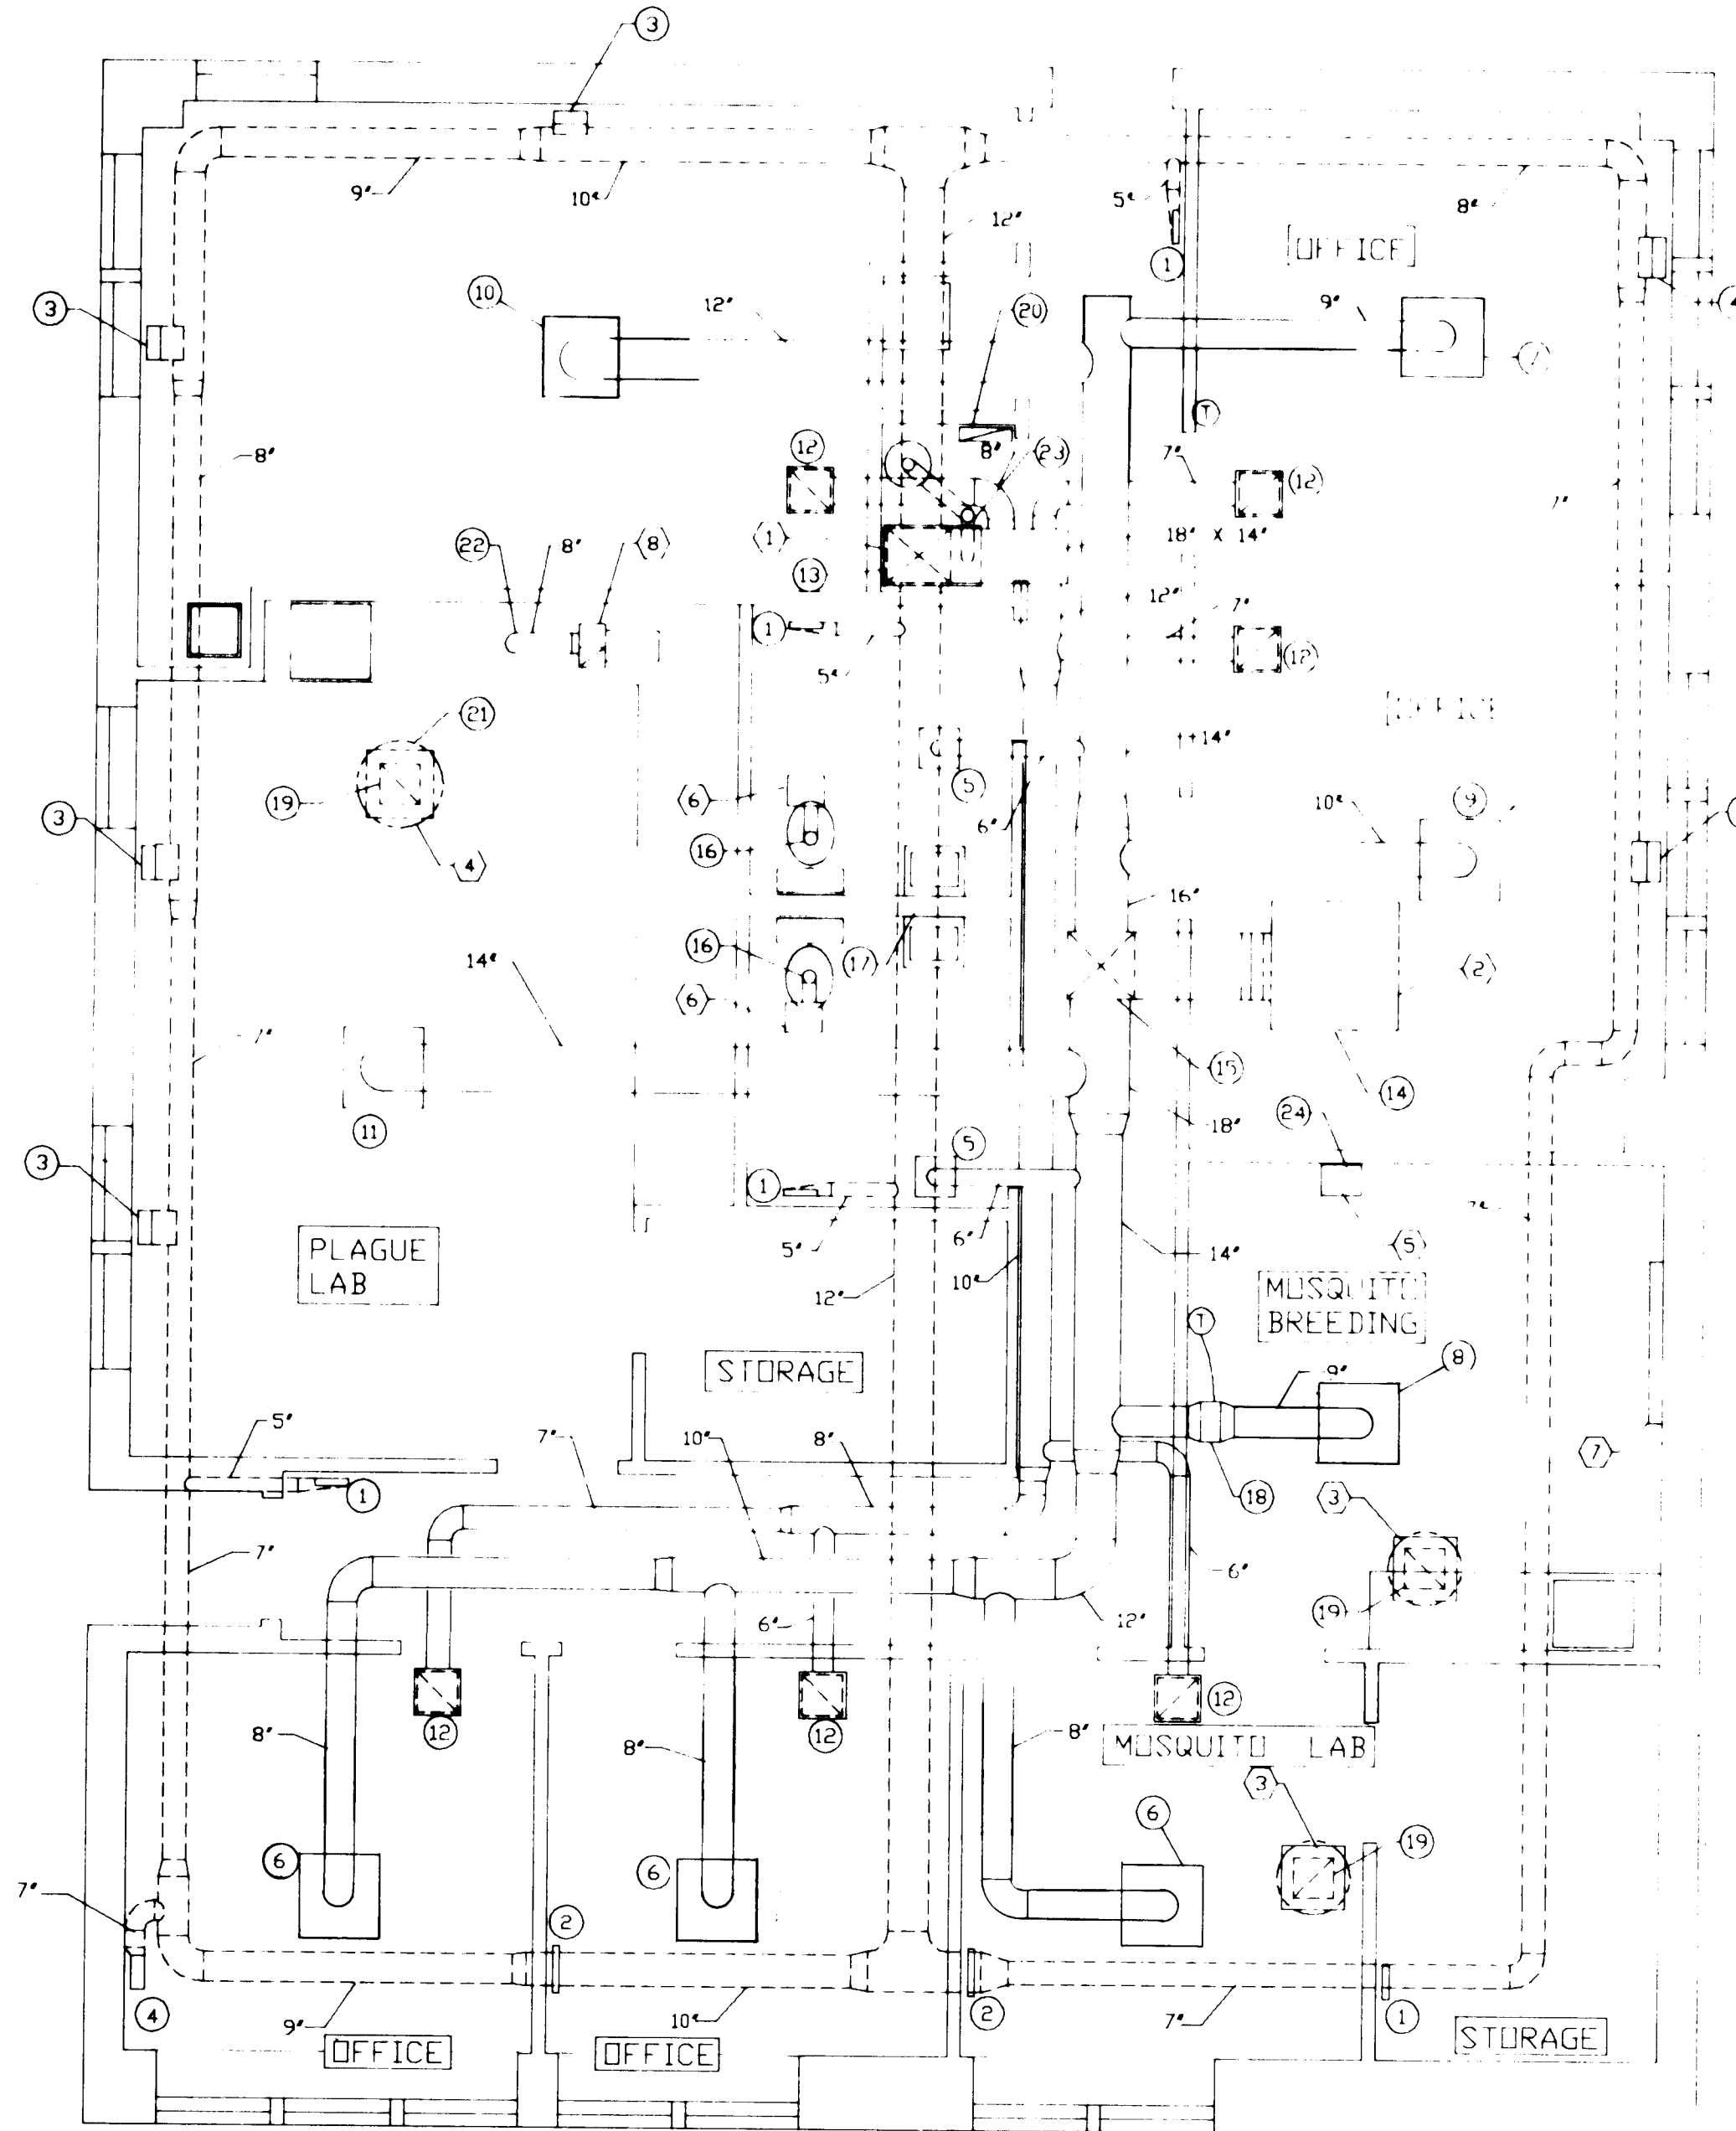

MECHANICAL PLAN
SCALE: 1/4" = 1'-0"

RECORD DRAWING based on information provided by the client. 1/18/88
 DATE: 04/86
 REV:

GENERAL NOTES

MECHANICAL CONTRACTOR SHALL BE RESPONSIBLE FOR ALL ROUGH-IN AND CONNECTION OF EQUIPMENT REQUIRING COLD WATER, HOT WATER, INDIRECT WASTE, DIRECT WASTE AND VENT, DRAIN PIPING AND GAS PIPING.

MECHANICAL CONTRACTOR SHALL FURNISH AND INSTALL ALL TRAPS, TAILPIECES, AND SUPPLIES FOR FINAL CONNECTION TO ALL EQUIPMENT.

COORDINATE ALL PIPING BELOW SLAB WITH STRUCTURAL DRAWINGS AND UNDERGROUND DUCTWORK.

ALL PIPING SHALL BE CONCEALED EXCEPT WHERE NOTED AND IN MECHANICAL ROOMS.

CARE SHALL BE TAKEN TO AVOID MECHANICAL DUCTWORK, ELECTRICAL EQUIPMENT AND A/P-HANDLING EQUIPMENT. THIS CONTRACTOR SHALL BE RESPONSIBLE FOR COORDINATING ROUTING OF PIPING WITH CEILING CONTRACTOR AND SHEETMETAL CONTRACTOR. RELOCATION OF PIPING REQUIRED DUE TO POOR CO-ORDINATION BY THIS CONTRACTOR SHALL BE AT THEIR OWN EXPENSE.

ALL TRENCHING AND BACKFILL FOR PIPING SHALL BE THE RESPONSIBILITY OF THIS CONTRACTOR.

ALL PLUMBING AND MECHANICAL SYSTEMS SHALL COMPLY WITH ALL APPLICABLE CODES, ORDINANCES, AND OSHA STANDARDS.

ALL WATER PIPING BELOW FLOOR SHALL BE TYPE "L" COPPER, NO JOINTS, WRAPPED COMPLETE WITH X-TRU-COAT OR WITH 2" WIDTH OF #101 SCOTCHWRAP TAPE.


CONNECT GAS LINES TO EACH PIECE OF GAS FIRED EQUIPMENT WITH GAS COCK, UNION, DIRT LEG, AND FLEXIBLE CONNECTION.

CAULK ALL OPENINGS INTO MOSQUITO BREEDING ROOM AIR TIGHT.

SPECIFIC NOTES - WASTE PIPING

1. SEE SITE PLAN FOR CONTINUATION.
2. 1 1/2" VENT FROM FLOOR DRAIN UP IN WALL TO ABOVE CEILING.
3. 2" VTR.
4. 3" VTR.
5. ROUTE 4" WASTE LINE FROM SAND TRAP TO DISPOSAL POND. SEE SITE PLAN FOR CONTINUATION.
6. 3/4" CW TO EXISTING EQUIPMENT BUILDING. SEE SITE PLAN FOR CONTINUATION.
7. 2" VENT LINE UP FROM BELOW GRADE AND UP ALONG WALL TO ABOVE ROOF.
8. ROUTE 3/4" COPPER DRAIN LINE ALONG WALL FROM HUMIDIFIER AND ELBOW DOWN INTO SINK.
9. SAND TRAP IN FLOOR. SEE DETAILS FOR CONSTRUCTION AND ARCHITECTURAL PLANS FOR EXACT LOCATION.
10. ~~PROVIDE 1" DIA. 10' OF 3/4" DIA. DRAIN AT BASE OF PH~~


DELETE

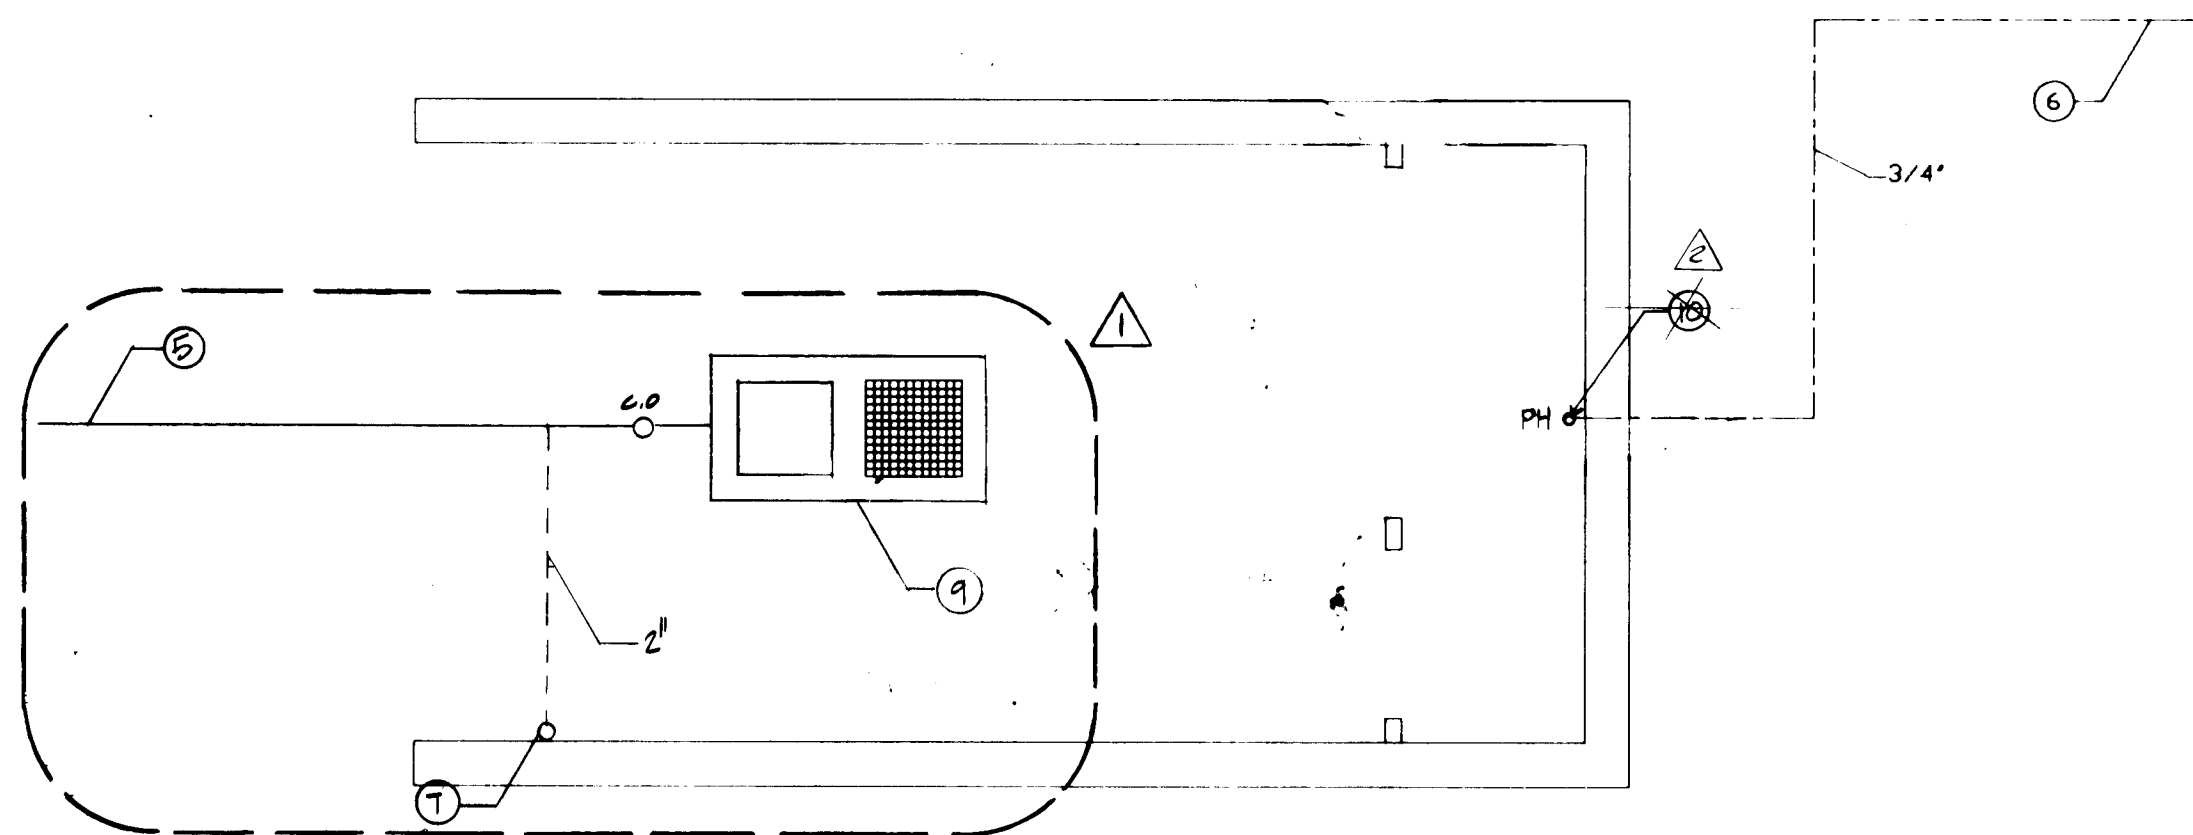

NOTE: PROVIDE AND INSTALL SHIVEL MOUNT FOR CAR WASH EQUIPMENT PER MANUFACTURER'S SPECS. CAR WASH EQUIPMENT IS OWNER'S.

CAR WASH PLAN

SCALE: 1/4" = 1'-0"

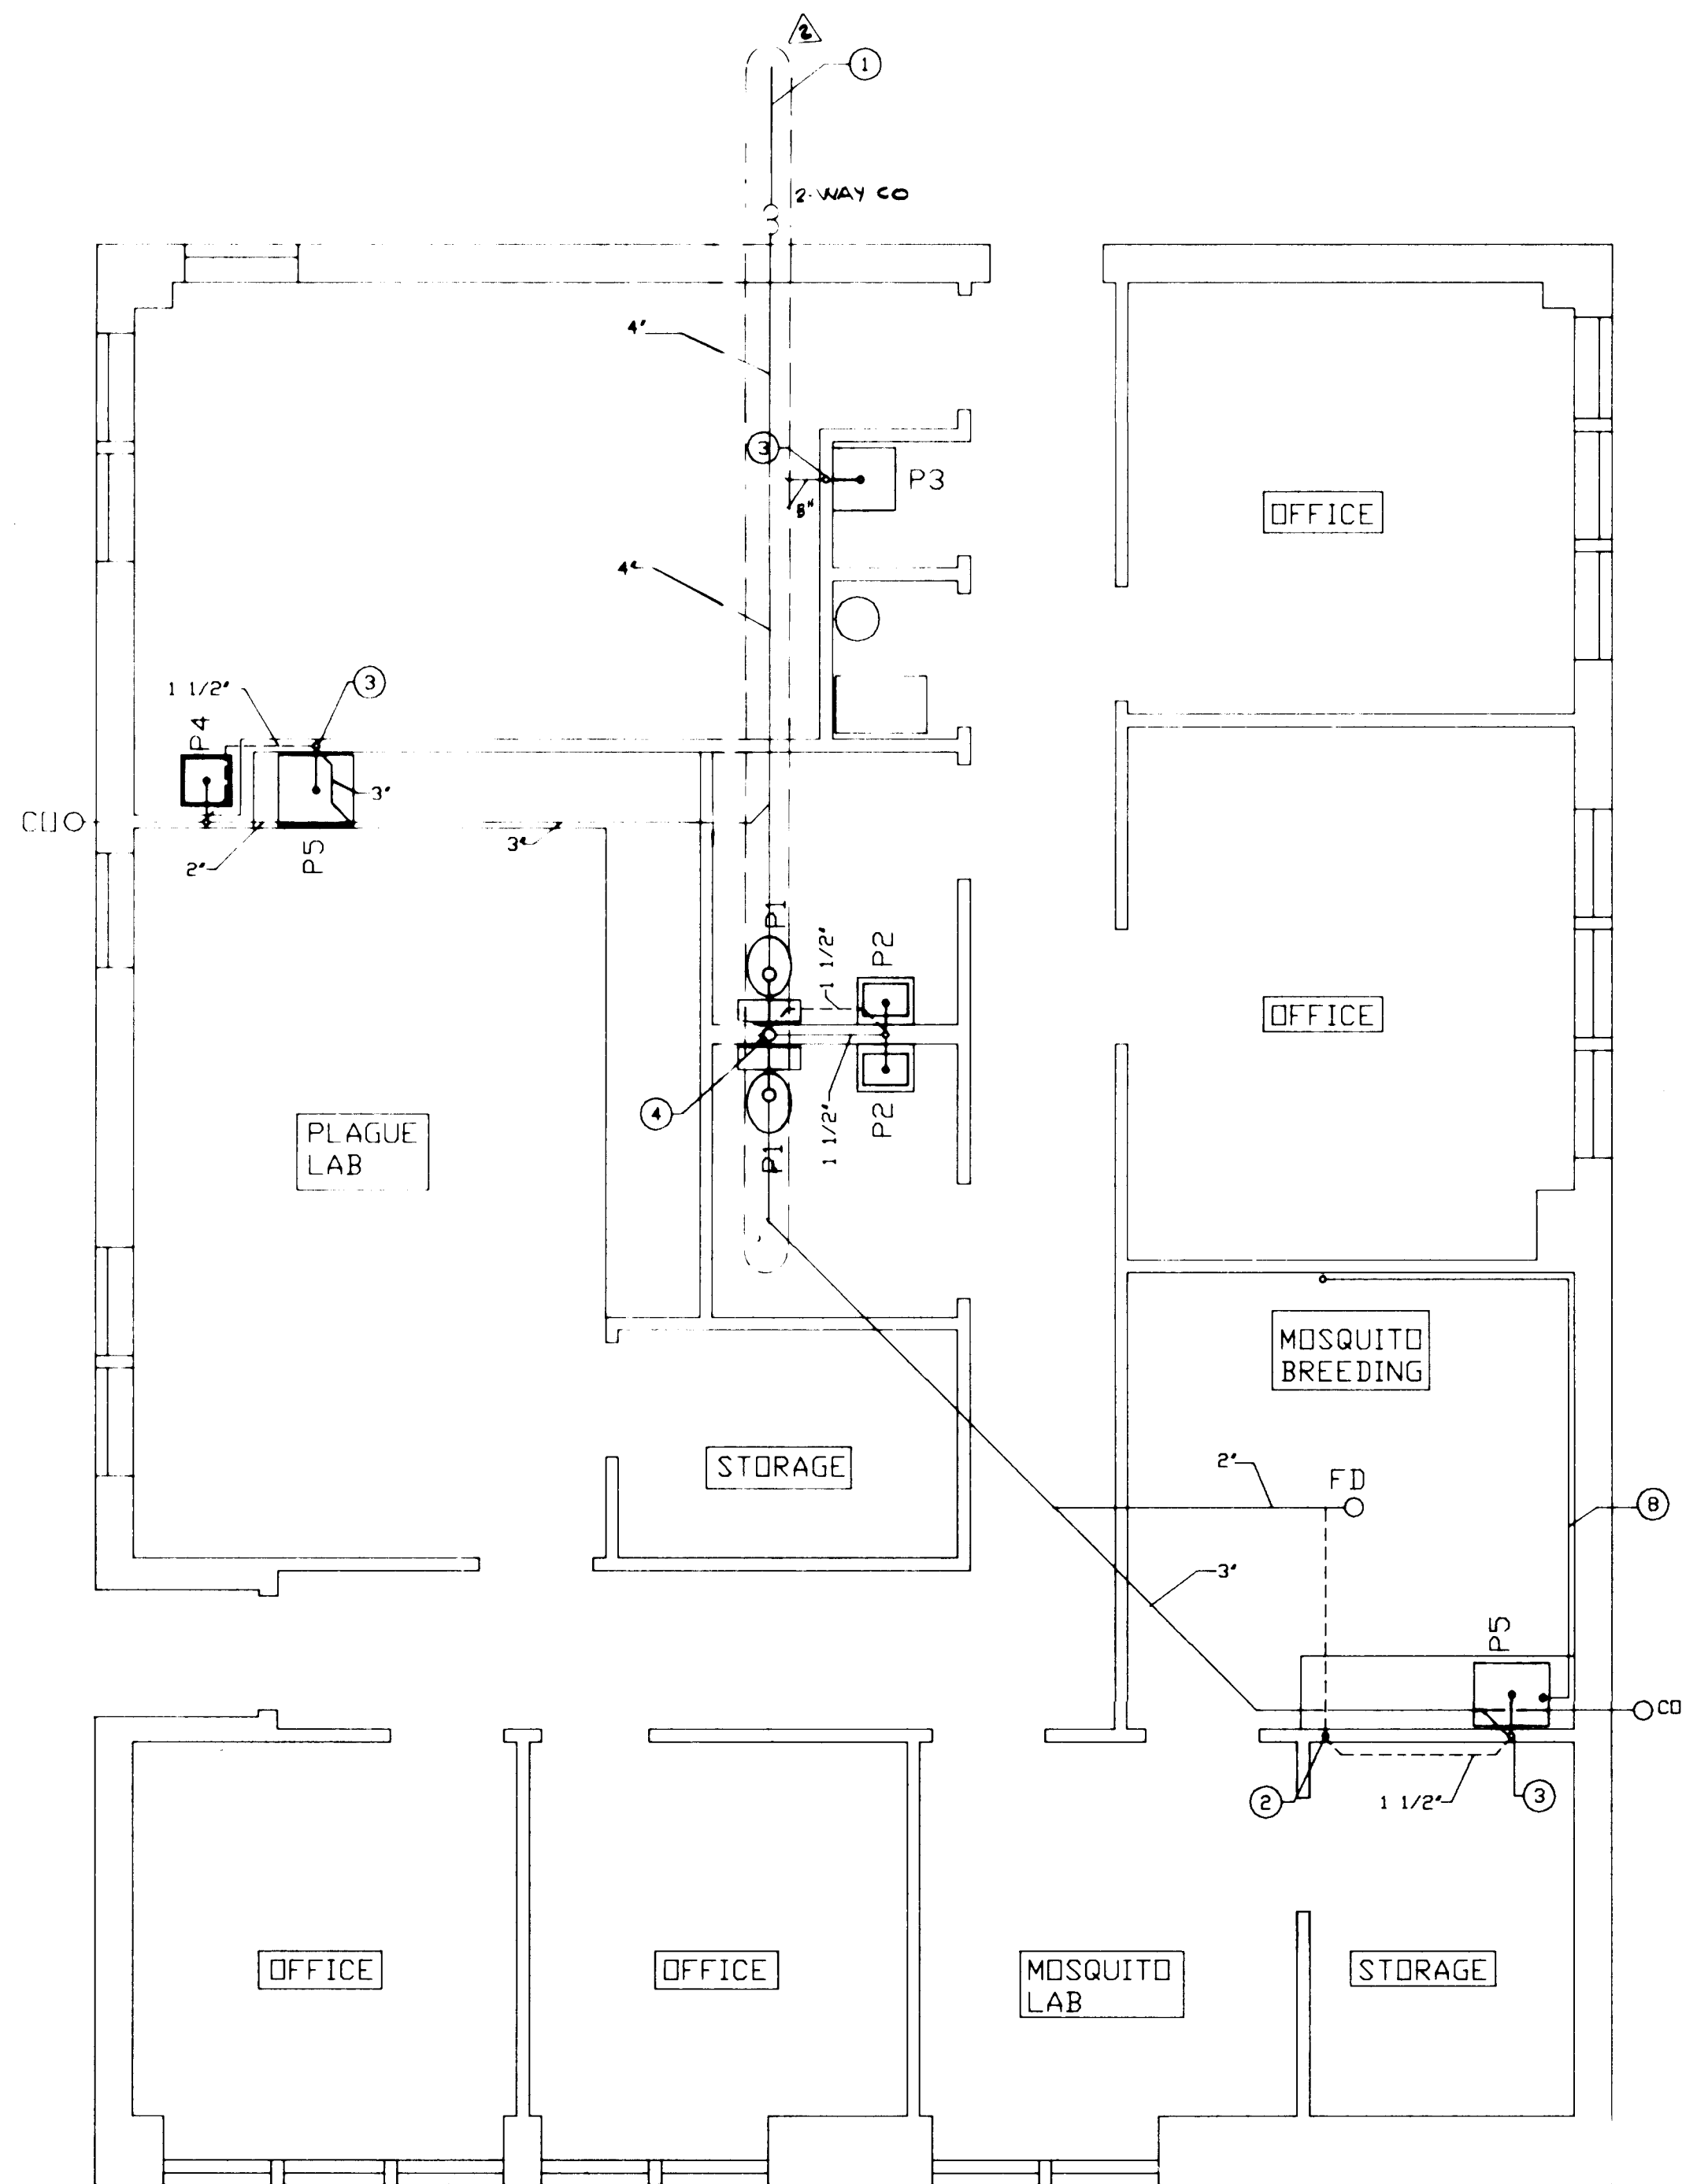

WASTE PIPING PLAN

SCALE: 1/4" = 1'-0"

APPROVAL OF AS BUILT DRAWINGS
Russell B. Smith
DATE 1-12-88

26 28071588


RECORD DRAWING
WASTE PIPING PLANS
CAR WASH
OFFICE / LAB BUILDING

MONTESSA PARK RENOVATION
FOR THE
CITY OF ALBUQUERQUE
ENVIRONMENTAL HEALTH DEPARTMENT

METHON ARCHITECTS GROUP
413 Montecito Drive NE
Albuquerque, NM 87108
505 / 888-8880

DATE: 01/15/88
REV: 01/15/88
10/18/87
PROJECT NUMBER 2807
SHEET 14 OF 17
CASHASH SAND TRAP REVISED
WASTE LINE LOCATION, POST HYDRAUNT

M3

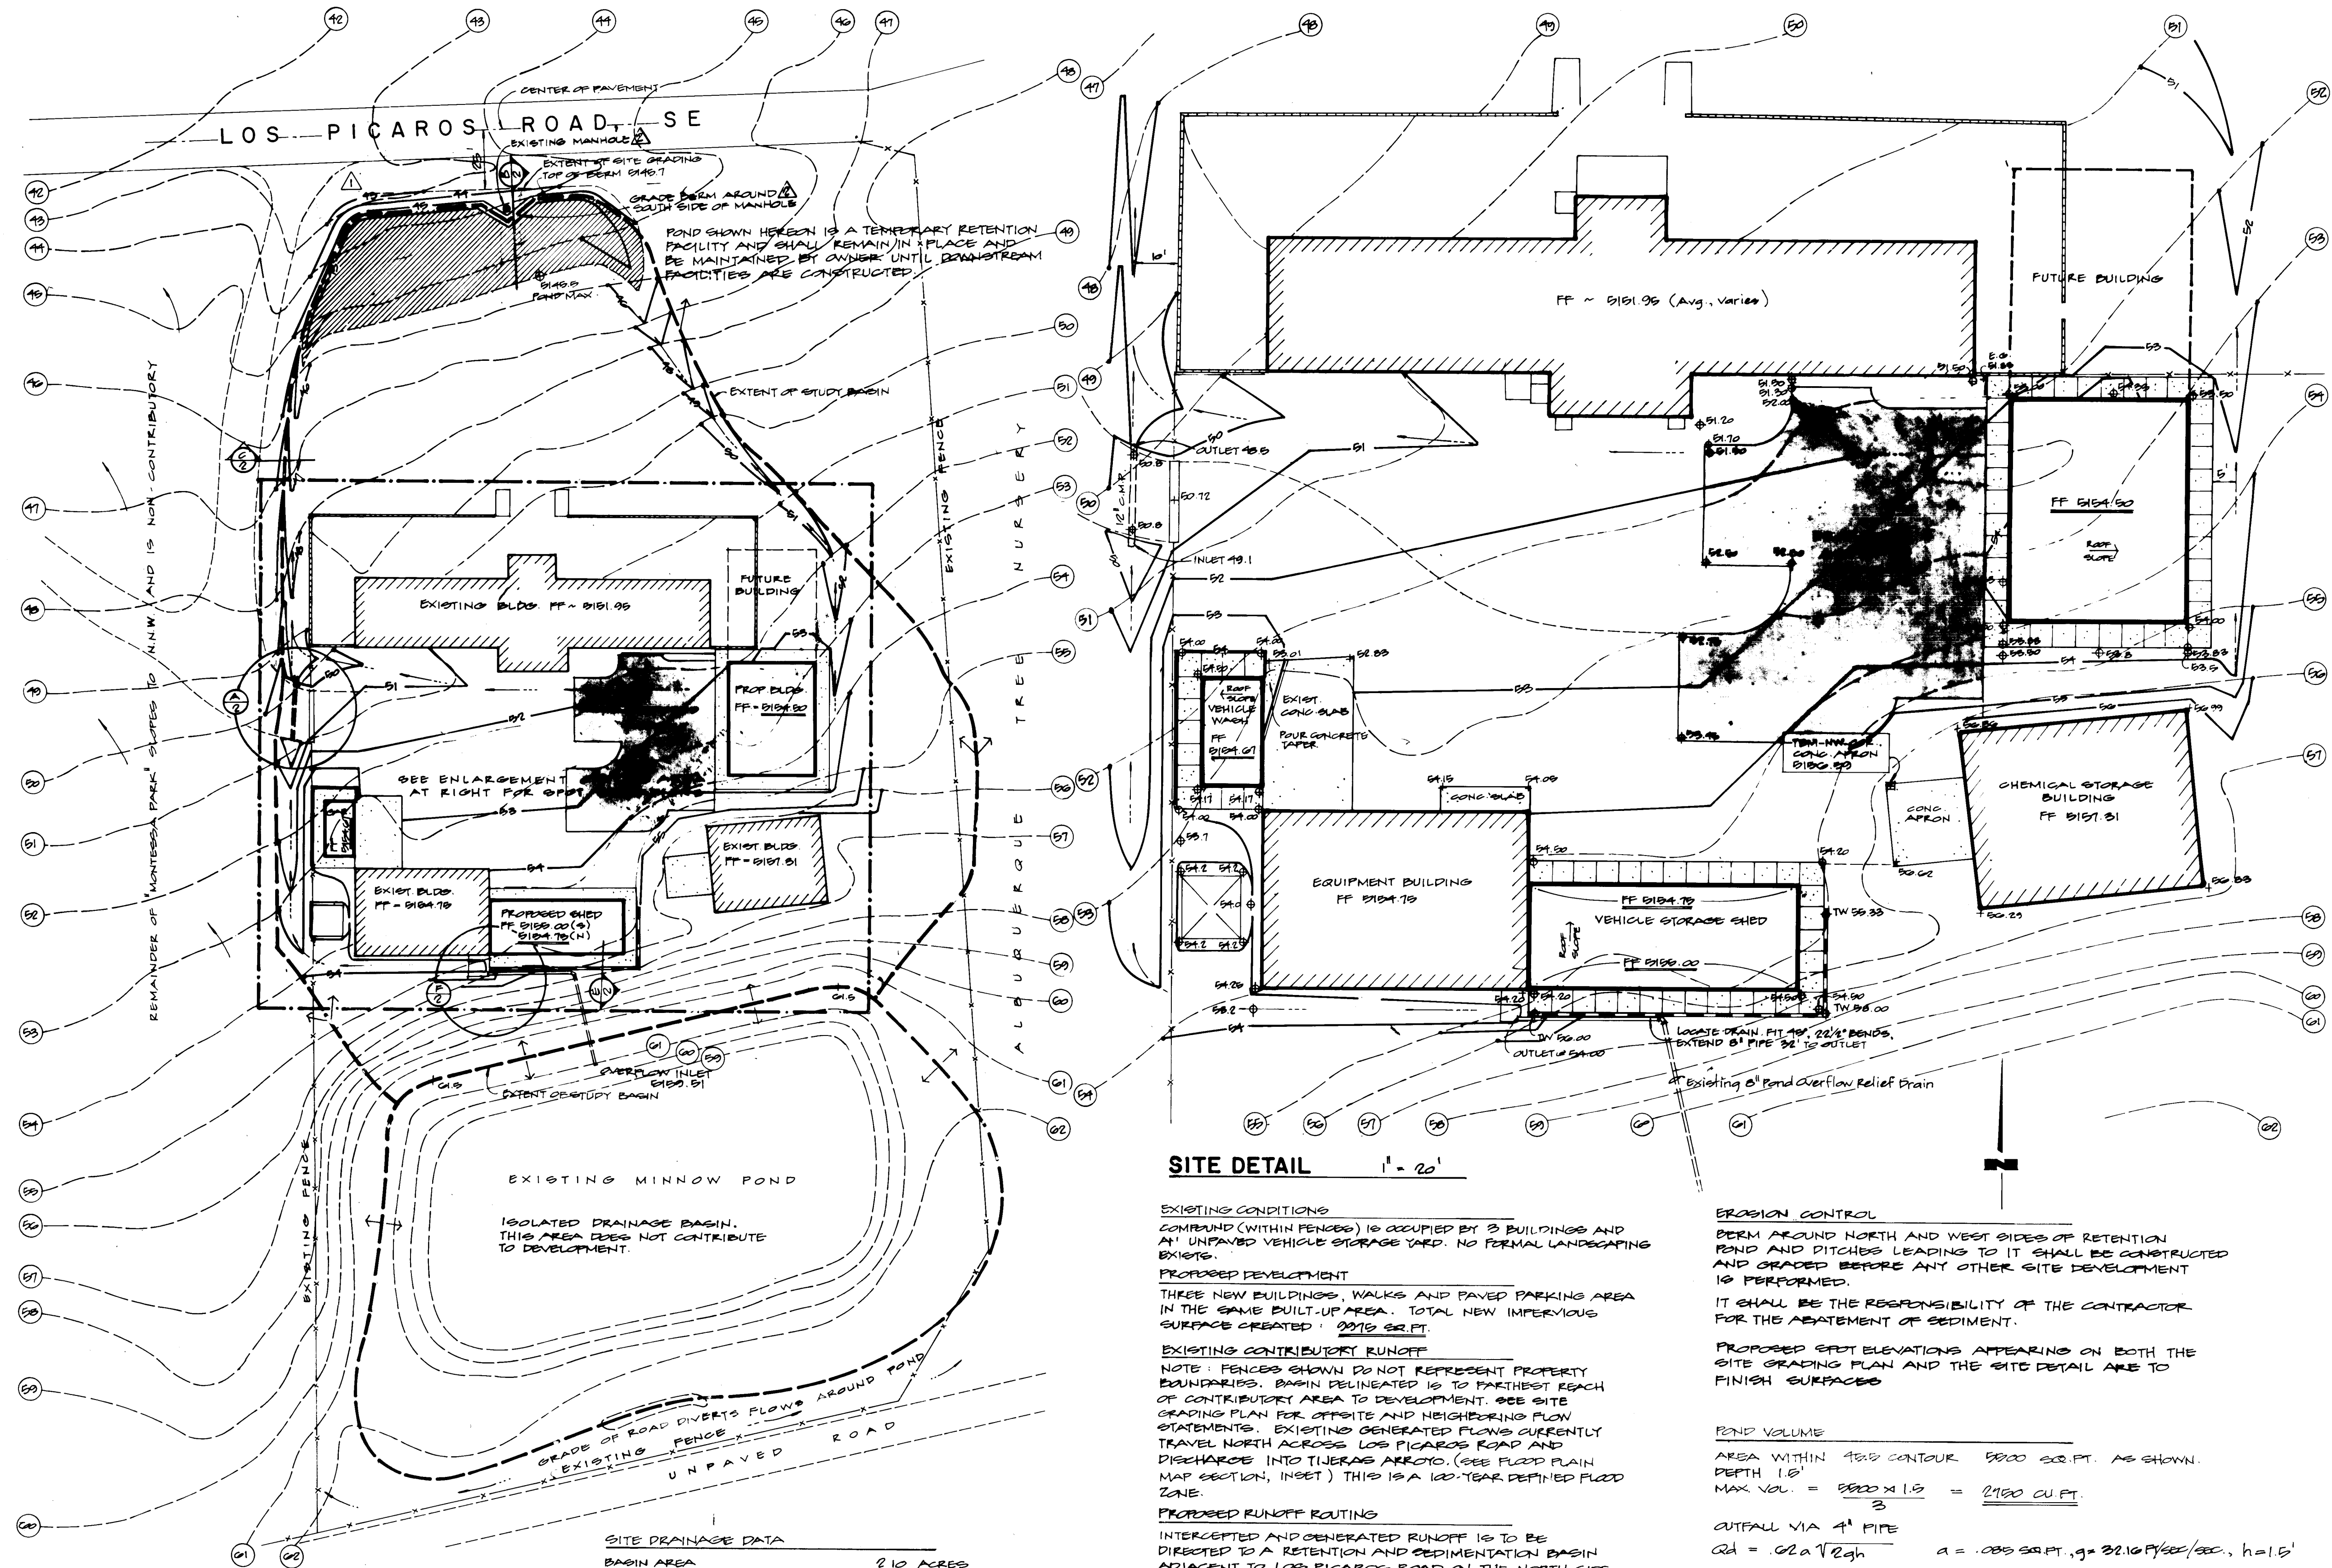

SITE DETAIL

EXISTING CONDITIONS
COMPOUND (WITHIN FENCES) IS OCCUPIED BY 3 BUILDINGS AND AN UNPAVED VEHICLE STORAGE YARD. NO FORMAL LANDSCAPING EXISTS.

PROPOSED DEVELOPMENT
THREE NEW BUILDINGS, WALKS AND PAVED PARKING AREA IN THE SAME BUILT-UP AREA. TOTAL NEW IMPERVIOUS SURFACE CREATED: 2075 SQ. FT.

EXISTING CONTRIBUTORY RUNOFF
NOTE: FENCES SHOWN DO NOT REPRESENT PROPERTY BOUNDARIES. BASIN DELINEATED IS TO FARTHEST REACH OF CONTRIBUTORY AREA TO DEVELOPMENT. SEE SITE GRADING PLAN FOR OFFSITE AND NEIGHBORING FLOW STATEMENTS. EXISTING GENERATED FLOWS CURRENTLY TRAVEL NORTH ACROSS LOS PICAROS ROAD AND DISCHARGE INTO TIERRAS ARROYO. (SEE FLOOD PLAIN MAP SECTION, INSET) THIS IS A 100-YEAR DEFINED FLOOD ZONE.

PROPOSED RUNOFF ROUTING
INTERCEPTED AND GENERATED RUNOFF IS TO BE DIRECTED TO A RETENTION AND SEDIMENTATION BASIN ADJACENT TO LOS PICAROS ROAD ON THE NORTH SIDE OF THIS DEVELOPMENT.

THERE SHALL BE NO RELEASE OF IMPROUNDED WATER ONTO LOS PICAROS ROAD.

BASIN SHALL REMAIN IN PLACE AND BE MAINTAINED BY OWNER UNTIL FUTURE DOWNSTREAM FACILITIES ARE IN PLACE.

LOS PICAROS ROAD HAS NO RECORDED RIGHT-OF-WAY WIDTH. TRE OF CONSTRUCTED BERM SHALL BE NO CLOSER THAN 25 FEET TO THE CENTERLINE OF ROAD PAVEMENT.

EROSION CONTROL

BERM AROUND NORTH AND WEST SIDES OF RETENTION POND AND PITCHES LEADING TO IT SHALL BE CONSTRUCTED AND GRADED BEFORE ANY OTHER SITE DEVELOPMENT IS PERFORMED.

IT SHALL BE THE RESPONSIBILITY OF THE CONTRACTOR FOR THE ADEQUATEMENT OF SEDIMENT.

PROPOSED SPOT ELEVATIONS APPEARING ON BOTH THE SITE GRADING PLAN AND THE SITE DETAIL ARE TO FINISH SURFACES.

POND VOLUME

AREA WITHIN 48" CONTOUR 5000 SQ. FT. AS SHOWN.

DEPTH 1.5'

MAX VOL. = $5000 \times 1.5 = 7500 \text{ CU. FT.}$

CUTFALL VIA 4" PIPE

$Q_d = Q_2 \sqrt{2gh}$ $a = .005 \text{ SQ. FT.} \cdot g = 32.16 \text{ FT./SEC.}^2, h = 1.5'$

$= .02(.005) \sqrt{2(32.16)(1.5)} = .02 \text{ CFS}$

TIME OF RELEASE = $\frac{2000 \text{ FT}^3}{.02 \text{ CFS}} = 9120 \text{ SEC. (1 h. 25 m.)}$

SITE DRAINAGE DATA

BASIN AREA 2.10 ACRES
SLOPE 4.5% ANG. TO H.N.W.
LENGTH OF RUN 240 FT.
TIME OF CONCENTRATION 10 MINUTES
100-YR. Q-HR. RAINFALL (P) 2.3 INCHES (P. 22.2, D. 1, D.P.M.)
SOILS GROUP (Blueprint Series) A (SOIL SURVEY BERNALILLO CO.)
INTENSITY 4.06 IN/HR. (P. 22.2, D. 1, D.P.M.)
IMPERVIOUS AREA 21%
CURVE NUMBER (PAIR RANGE) 54 (P. 22.2, C. 2, D.P.M.)
COMPOSITE CN 51 (P. 22.2, C. 3, D.P.M.)
DIRECT RUNOFF .35 INCHES (P. 22.2, C. 4, D.P.M.)

VOLUME OF RUNOFF $\frac{35}{12} \times 2.10 \times 43560 = 2000 \text{ CU. FT.}$

$Q_{100} = .40 \times 4.06 \times 2.10 = 3.40 \text{ CFS PEAK}$
 $Q_{10} = .087 \times 4.06 = 2.08 \text{ CFS}$

FLOWS ARE TOTAL AT ENTRY TO POND

VICINITY MAP

P-17-7



FLOOD PLAIN MAP
PORTION, FLOODWAY AND FLOOD BOUNDARY MAP
CITY OF ALBUQUERQUE, NEW MEXICO
PANEL 41 OF 50.

LEGEND

- EXISTING CONTOUR
- PROPOSED CONTOUR
- EXISTING SPOT ELEVATIONS
- PROPOSED SPOT ELEVATIONS
- EXISTING BUILDING
- PROPOSED BUILDING
- EXTENT OF RETENTION AND SEDIMENTATION BASIN
- FLOODLINE
- DIVISION OF FLOWS
- RETAINING WALL
- FENCE
- EXISTING CONCRETE
- NEW CONCRETE
- NEW ASPHALT

CITY OF ALBUQUERQUE
ENVIRONMENTAL HEALTH DEPARTMENT


TITLE: SITE DRAINAGE & GRADING MONTESSA PARK RENOVATION

APPROVALS	ENGINEER	DATE	APPROVALS	ENGINEER	DATE
CITY Engineer			Liquid Waste		
A.C.E.-Design			Traffic		
A.C.E.-Hydrology			Water		

DRAWING NO. 2807 MAP NO. P-17 SHEET DI 2

Handwritten signature and date: 1-12-88

HALL ENGINEERING COMPANY INC.
337 EUBANK N.E., SUITE 103
ALBUQUERQUE, NEW MEXICO 87123
Phones: (505) 292-1115 & 292-1116

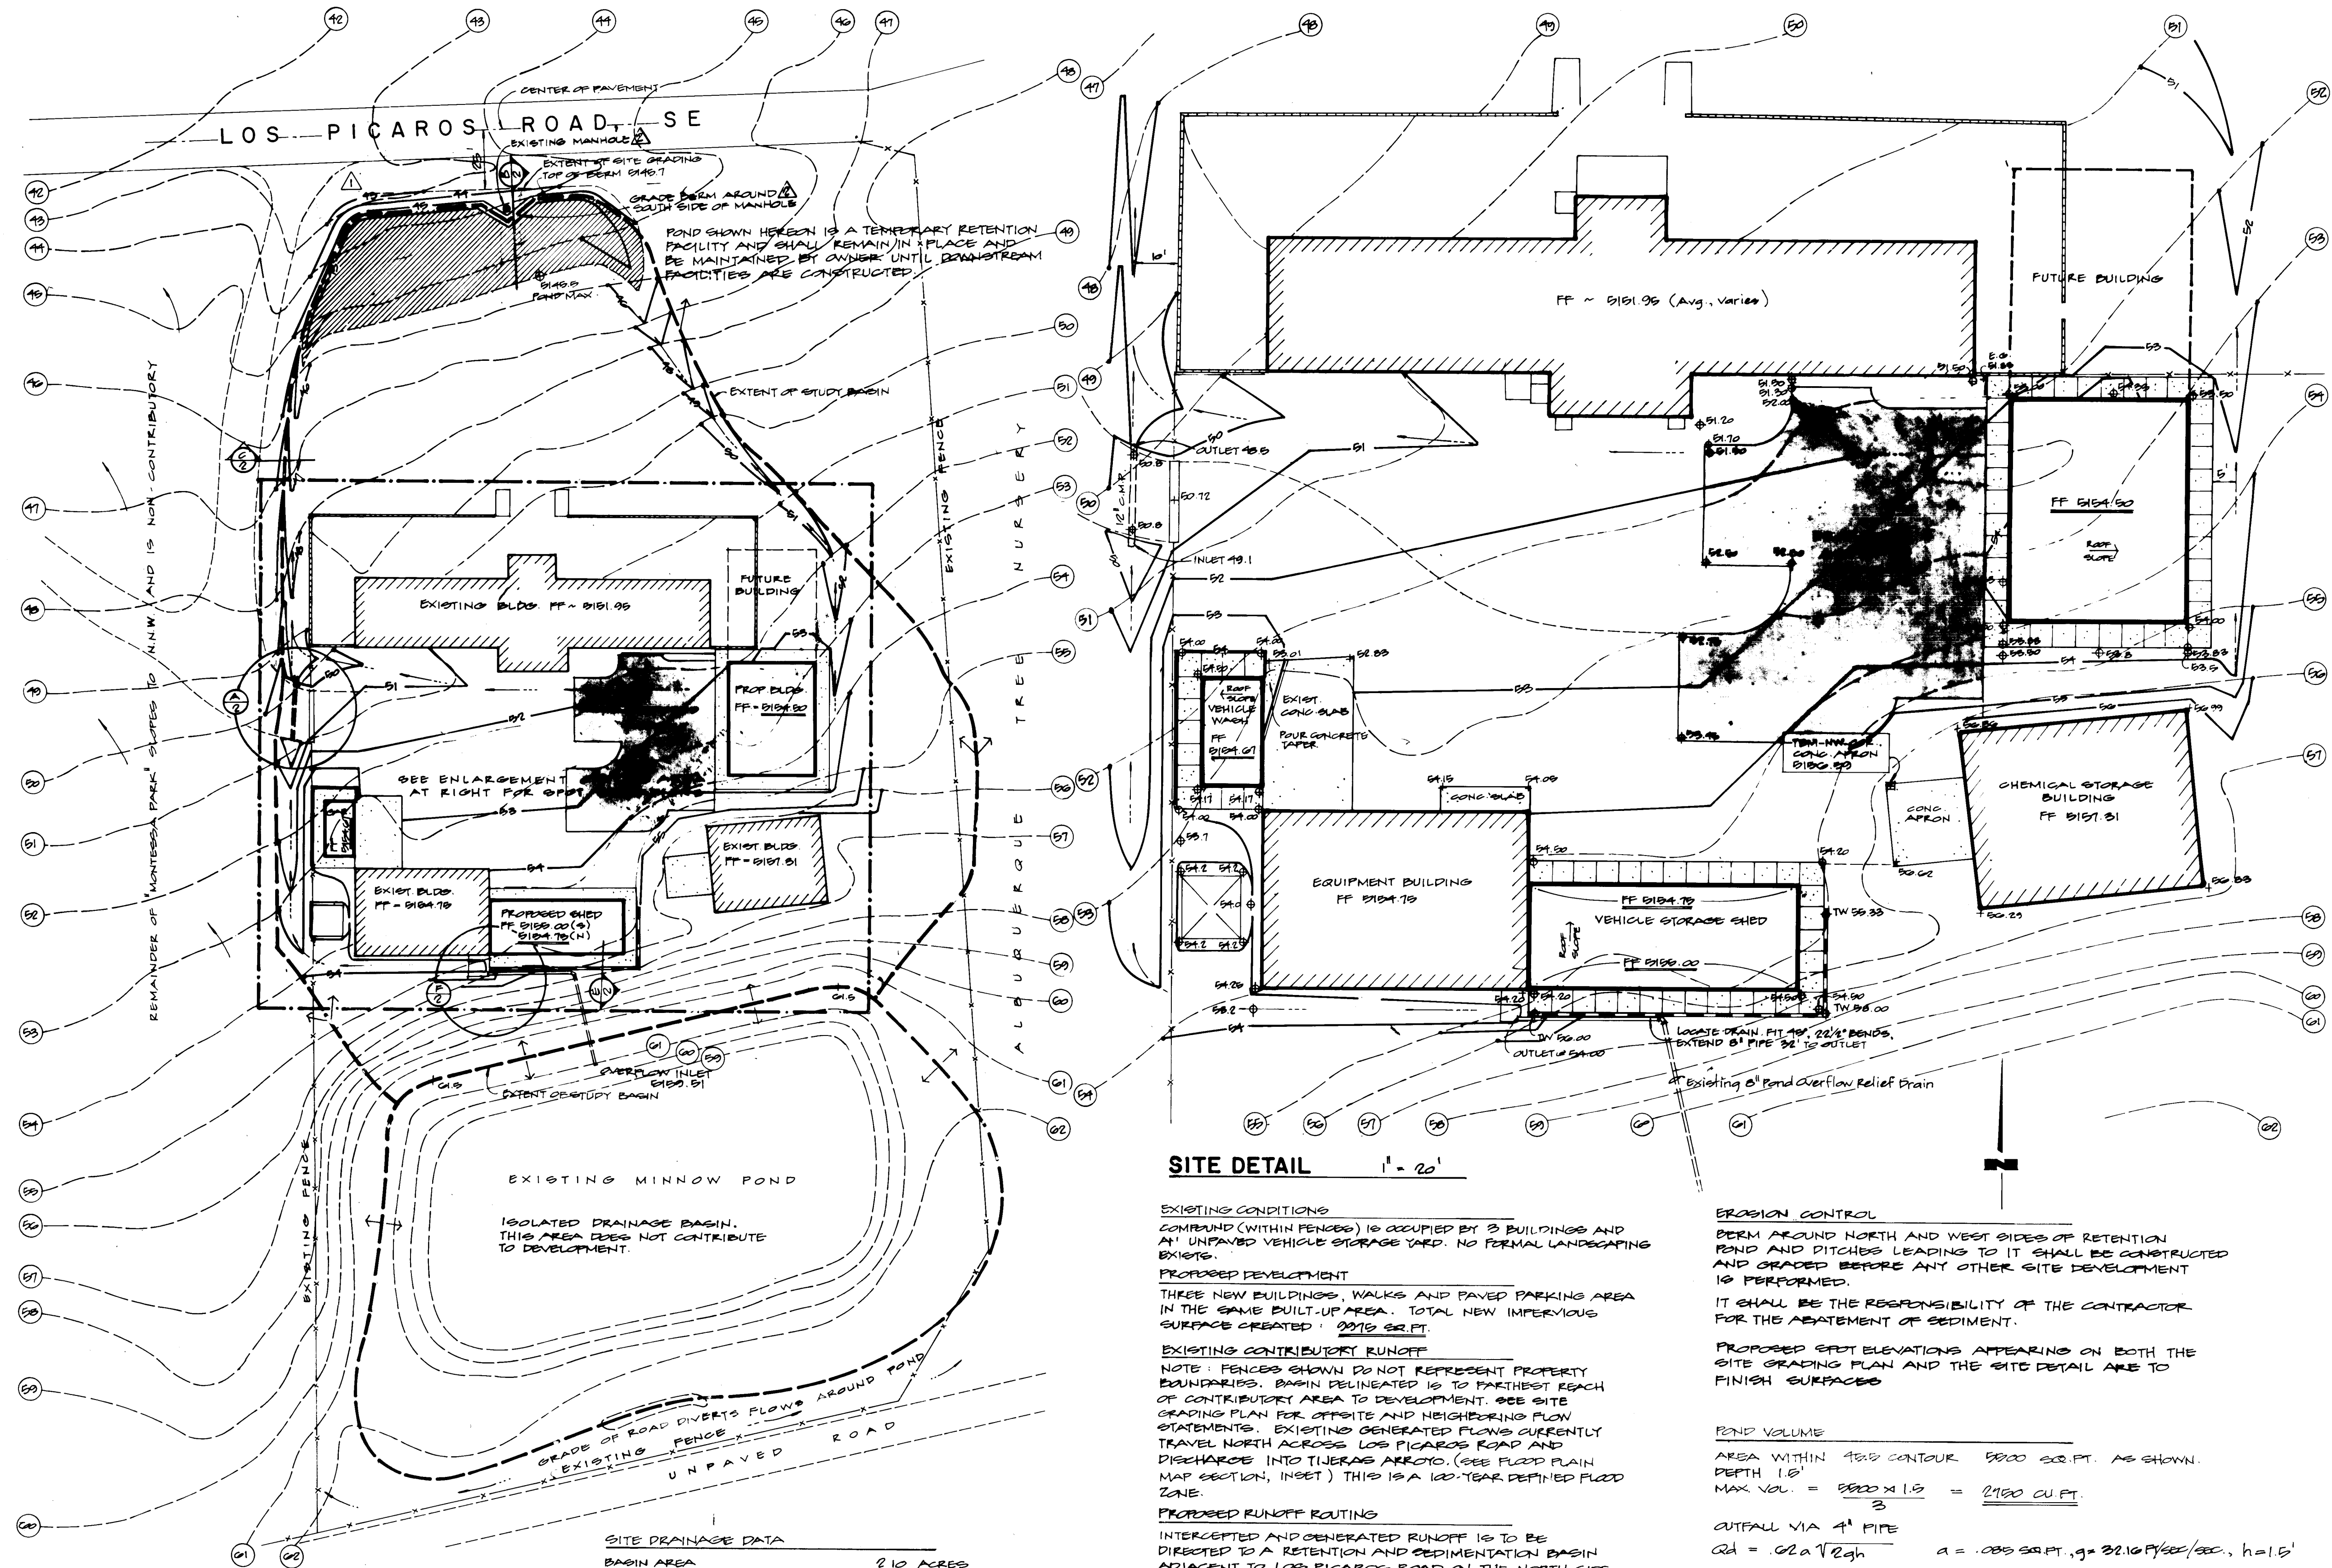

SITE GRADING

SITE DRAINAGE DATA

BASIN AREA 2.10 ACRES
SLOPE 4.5% ANG. TO H.N.W.
LENGTH OF RUN 240 FT.
TIME OF CONCENTRATION 10 MINUTES
100-YR. Q-HR. RAINFALL (P) 2.3 INCHES (P. 22.2, D. 1, D.P.M.)
SOILS GROUP (Blueprint Series) A (SOIL SURVEY BERNALILLO CO.)
INTENSITY 4.06 IN/HR. (P. 22.2, D. 1, D.P.M.)
IMPERVIOUS AREA 21%
CURVE NUMBER (PAIR RANGE) 54 (P. 22.2, C. 2, D.P.M.)
COMPOSITE CN 51 (P. 22.2, C. 3, D.P.M.)
DIRECT RUNOFF .39 INCHES (P. 22.2, C. 4, D.P.M.)
VOLUME OF RUNOFF $\frac{39}{12} \times 2.10 \times 193600 = 2000 \text{ CU. FT.}$
 $Q_{100} = .40 \times 4.06 \times 2.10 = 4.08 \text{ CFS PEAK}$
 $Q_{10} = .087 \times 4.06 = 2.08 \text{ CFS}$
FLOWS ARE TOTAL AT ENTRY TO POND


SITE DETAIL

EXISTING CONDITIONS
COMPOUND (WITHIN FENCES) IS OCCUPIED BY 3 BUILDINGS AND AN UNPAVED VEHICLE STORAGE YARD. NO FORMAL LANDSCAPING EXISTS.
PROPOSED DEVELOPMENT
THREE NEW BUILDINGS, WALKS AND PAVED PARKING AREA IN THE SAME BUILT-UP AREA. TOTAL NEW IMPERVIOUS SURFACE CREATED: 2075 SQ. FT.
EXISTING CONTRIBUTORY RUNOFF
NOTE: FENCES SHOWN DO NOT REPRESENT PROPERTY BOUNDARIES. BASIN DELINEATED IS TO FARTHEST REACH OF CONTRIBUTORY AREA TO DEVELOPMENT. SEE SITE GRADING PLAN FOR OFFSITE AND NEIGHBORING FLOW STATEMENTS. EXISTING GENERATED FLOWS CURRENTLY TRAVEL NORTH ACROSS LOS PICAROS ROAD AND DISCHARGE INTO TIERRAS ARROYO. (SEE FLOOD PLAIN MAP SECTION, INSET) THIS IS A 100-YEAR DEFINED FLOOD ZONE.
PROPOSED RUNOFF ROUTING
INTERCEPTED AND GENERATED RUNOFF IS TO BE DIRECTED TO A RETENTION AND SEDIMENTATION BASIN ADJACENT TO LOS PICAROS ROAD ON THE NORTH SIDE OF THIS DEVELOPMENT.
THERE SHALL BE NO RELEASE OF IMPROUNDED WATER ONTO LOS PICAROS ROAD.
BASIN SHALL REMAIN IN PLACE AND BE MAINTAINED BY OWNER UNTIL FUTURE DOWNSTREAM FACILITIES ARE IN PLACE.

LOS PICAROS ROAD HAS NO RECORDED RIGHT-OF-WAY WIDTH. TRE OF CONSTRUCTED BERM SHALL BE NO CLOSER THAN 20 FEET TO THE CENTERLINE OF ROAD PAVEMENT.

EROSION CONTROL
BERM AROUND NORTH AND WEST SIDES OF RETENTION POND AND PITCHES LEADING TO IT SHALL BE CONSTRUCTED AND GRADED BEFORE ANY OTHER SITE DEVELOPMENT IS PERFORMED.
IT SHALL BE THE RESPONSIBILITY OF THE CONTRACTOR FOR THE MAINTENANCE OF SEDIMENT.
PROPOSED SPOT ELEVATIONS APPEARING ON BOTH THE SITE GRADING PLAN AND THE SITE DETAIL ARE TO FINISH SURFACES

POND VOLUME
AREA WITHIN 42.5' CONTOUR 5000 SQ. FT. AS SHOWN.
DEPTH 1.5'
MAX VOL. = $5000 \times 1.5 = 2150 \text{ CU. FT.}$
OUTFALL VIA 4" PIPE
 $Q_d = Q_{2.5} \sqrt{2gh} \quad a = .005 \text{ SQ. FT. } g = 32.16 \text{ FT/SEC/SEC. } h = 1.5'$
 $= .02(2.08) \sqrt{2(32.16)(1.5)} = .02 \text{ CFS}$
TIME OF RELEASE = $\frac{2000 \text{ FT}^3}{.02 \text{ CFS}} = 9120 \text{ SEC. (1 h. 25 m.)}$

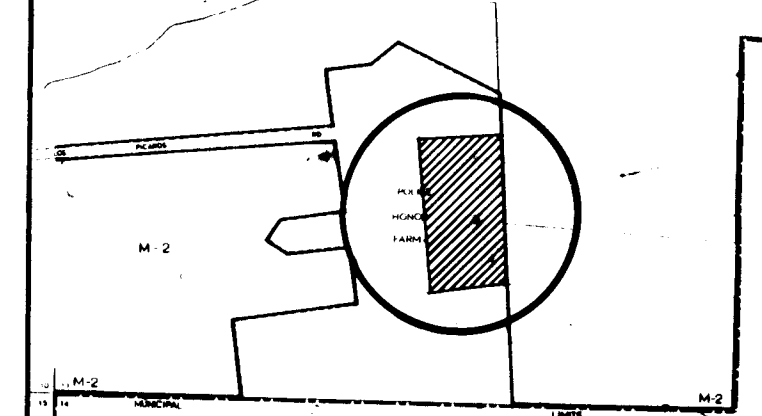

VICINITY MAP

FLOOD PLAIN MAP
PORTION, FLOODWAY AND FLOOD BOUNDARY MAP
CITY OF ALBUQUERQUE, NEW MEXICO
PANEL 41 OF 50.

- LEGEND
- EXISTING CONTOUR
 - PROPOSED CONTOUR
 - EXISTING SPOT ELEVATIONS
 - PROPOSED SPOT ELEVATIONS
 - EXISTING BUILDING
 - PROPOSED BUILDING
 - EXTENT OF RETENTION AND SEDIMENTATION BASIN
 - FLOWLINE
 - DIVISION OF FLOWS
 - RETAINING WALL
 - FENCE
 - EXISTING CONCRETE
 - NEW CONCRETE
 - NEW ASPHALT

CITY OF ALBUQUERQUE ENVIRONMENTAL HEALTH DEPARTMENT					
TITLE: SITE DRAINAGE & GRADING MONTESSA PARK RENOVATION					
APPROVALS	ENGINEER	DATE	APPROVALS	ENGINEER	DATE
CITY Engineer			Liquid Waste		
A.C.E.-Design			Traffic		
A.C.E.-Hydrology			Water		
DRAWING NO. 2807		MAP NO. P-17		SHEET DI 2	

HALL ENGINEERING COMPANY INC.
337 EUBANK N.E., SUITE 103
ALBUQUERQUE, NEW MEXICO 87123
Phone: (505) 292-1115 & 292-1116

FIXTURE SCHEDULE


- P1 **WATER CLOSET:** AMERICAN STANDARD MODEL 2108.408, RIM HEIGHT AT 18" AFF, COMPLETE WITH TANK AND WATER SAVER TRIM, BOLT CAPS, SUPPLY STOP AND WHITE PLASTIC SEAT. 4" WASTE, 2" OR 4" VENT, 1/2" CW.
- P2 **LAUATORY:** AMERICAN STANDARD MODEL 0373.027, WITH WALL HANGER AND RIM MOUNTED AT 31" AFF. PROVIDE WITH SINGLE HANDLE FAUCET, P-TRAP, AND SUPPLY STOPS. INSULATE P-TRAP AND HW SUPPLY WITH 1" FIBERGLASS WITH ALUMINUM PROTECTIVE COVERING. 1 1/2" WASTE, 1 1/2" VENT, 1/2" CW, 1/2" HW.
- P3 **SERVICE SINK:** AMERICAN STANDARD NO. 7692.049, WITH NO 8341.075 TRIM, RIM GUARD, WALL HANGER, AND STANDARD TRAP. 2" WASTE, 1 1/2" VENT, 1/2" CW, 1/2" HW.
- P4 **SINK:** ELKAY MODEL LR-1517, 15" X 17" X 7" DEEP, 18 GAUGE, TYPE 304 STAINLESS STEEL WITH SOUND DAMPERING, SELF RIMMING, P-TRAP, CRUMB CUP STRAINER, SINGLE FAUCET HOLE, LK-2088-13 GOOSENECK FAUCET. 1 1/2" WASTE, 1 1/2" VENT, 1/2" CW, 1/2" HW.
- P5 **SINK:** ELKAY MODEL DLR-3122-12, 28" X 16" X 11" DEEP, 18 GAUGE, 302 STAINLESS STEEL, SELF RIMMING, WITH P-TRAP, CRUMB CUP STRAINER, AND LK-4102 FAUCET. 1 1/2" WASTE, 1 1/2" VENT, 1/2" CW, 1/2" HW.
- P6 **WATER HEATER:** AO SMITH MODEL NO. PGC-50, NATURAL GAS FIRED WATER HEATER ORFICED FOR 5000' ELEVATION. 40,000 BTUH INPUT, 50 GALLON STORAGE CAPACITY, GLASS LINED TANK WITH MAGNESIUM ANODE, T & P RELIEF VALVE, AND 3" DIA. FLUE.
- P7 **GAS COCK:** CHICAGO FAUCET NO. 907

- HB **HOSE BIB:** SMITH FIG. 5509 FREEZEPROOF HOSE BIB WITH VACUUM BREAKER
- FD **FLOOR DRAIN:** SMITH FIG. 2010-A WITH 5" DIA ADJUSTABLE POLISHED BRONZE TOP, AND VANDEL PROOF SCREWS.
- PH **POST HYDRANT:** SMITH MODEL 5910 WITH 3/4" HOSE CONNECTION. VACUUM BREAKER, CAST IRON CASING GUARD AND REMOVABLE "T" HANDLE.
- CO **CLEANOUT:** (FOR APPLICABLE FINISH)
- A. CONCRETE, CERAMIC TILE, OR QUARRY TILE: SMITH FIG. 4023
- B. VINYL TILE OR ASBESTOS TILE: SMITH FIG 4143
- C. CARPET: SMITH FIG. 4023-Y WITH CARPET MARKER.

SPECIFIC NOTES - WATER AND GAS PIPING PLAN

1. SHUT OFF VALVE IN VALVE BOX. SEE SITE PLAN FOR CONTINUATION.
2. 1" CW UP FROM BELOW GRADE. ROUTE UP TO CEILING SPACE.
3. HW AND CW LINES IN CEILING SPACE.
4. 3/4" CW WITH SHUT-OFF VALVE AND UNION TO WATER HEATER INLET. 3/4" HW WITH UNION TO WATER HEATER OUTLET. ROUTE 3/4" T & P RELIEF LINE TO SERVICE SINK.
5. 3/4" CW AND 1/2" HW DOWN INTO PLUMBING WALL AND ROUTE TO FIXTURE.
6. 1/2" CW DOWN IN WALL TO HUMIDIFIER WITH SHUT-OFF VALVE.
7. 1/2" HW AND 3/4" CW DOWN IN WALL TO FIXTURE. ROUTE 3/4" CW TO HB.
8. 1/2" HW AND 1/2" CW DOWN IN WALL TO FIXTURE.
9. GAS METER AND PRESSURE REGULATOR BY UTILITY COMPANY. ALL FEES PAID BY CONTRACTOR. SIZE FOR A TOTAL CONNECTED LOAD OF 150,000 BTUH.
10. 3/4" GAS LINE UP IN WALL TO ABOVE CEILING.
11. 3/4" GAS LINE FROM CEILING. ROUTE TO FURNACE AND WATER HEATER WITH SHUT-OFF VALVE, DIRT LEG, AND FLEX CONNECTION AT EACH APPLIANCE.
12. 1/2" GAS LINE DOWN IN WALL TO P7 AT 6" ABOVE COUNTER.
13. 1/4" CW UP THRU ROOF AND ROUTE TO EVAPORATIVE COOLER. SEE DETAIL.

NOTE: PLACE WATER PIPES BETWEEN CEILING AND 12" R-19 INSULATION OR INSULATE PIPES PER SPECS.

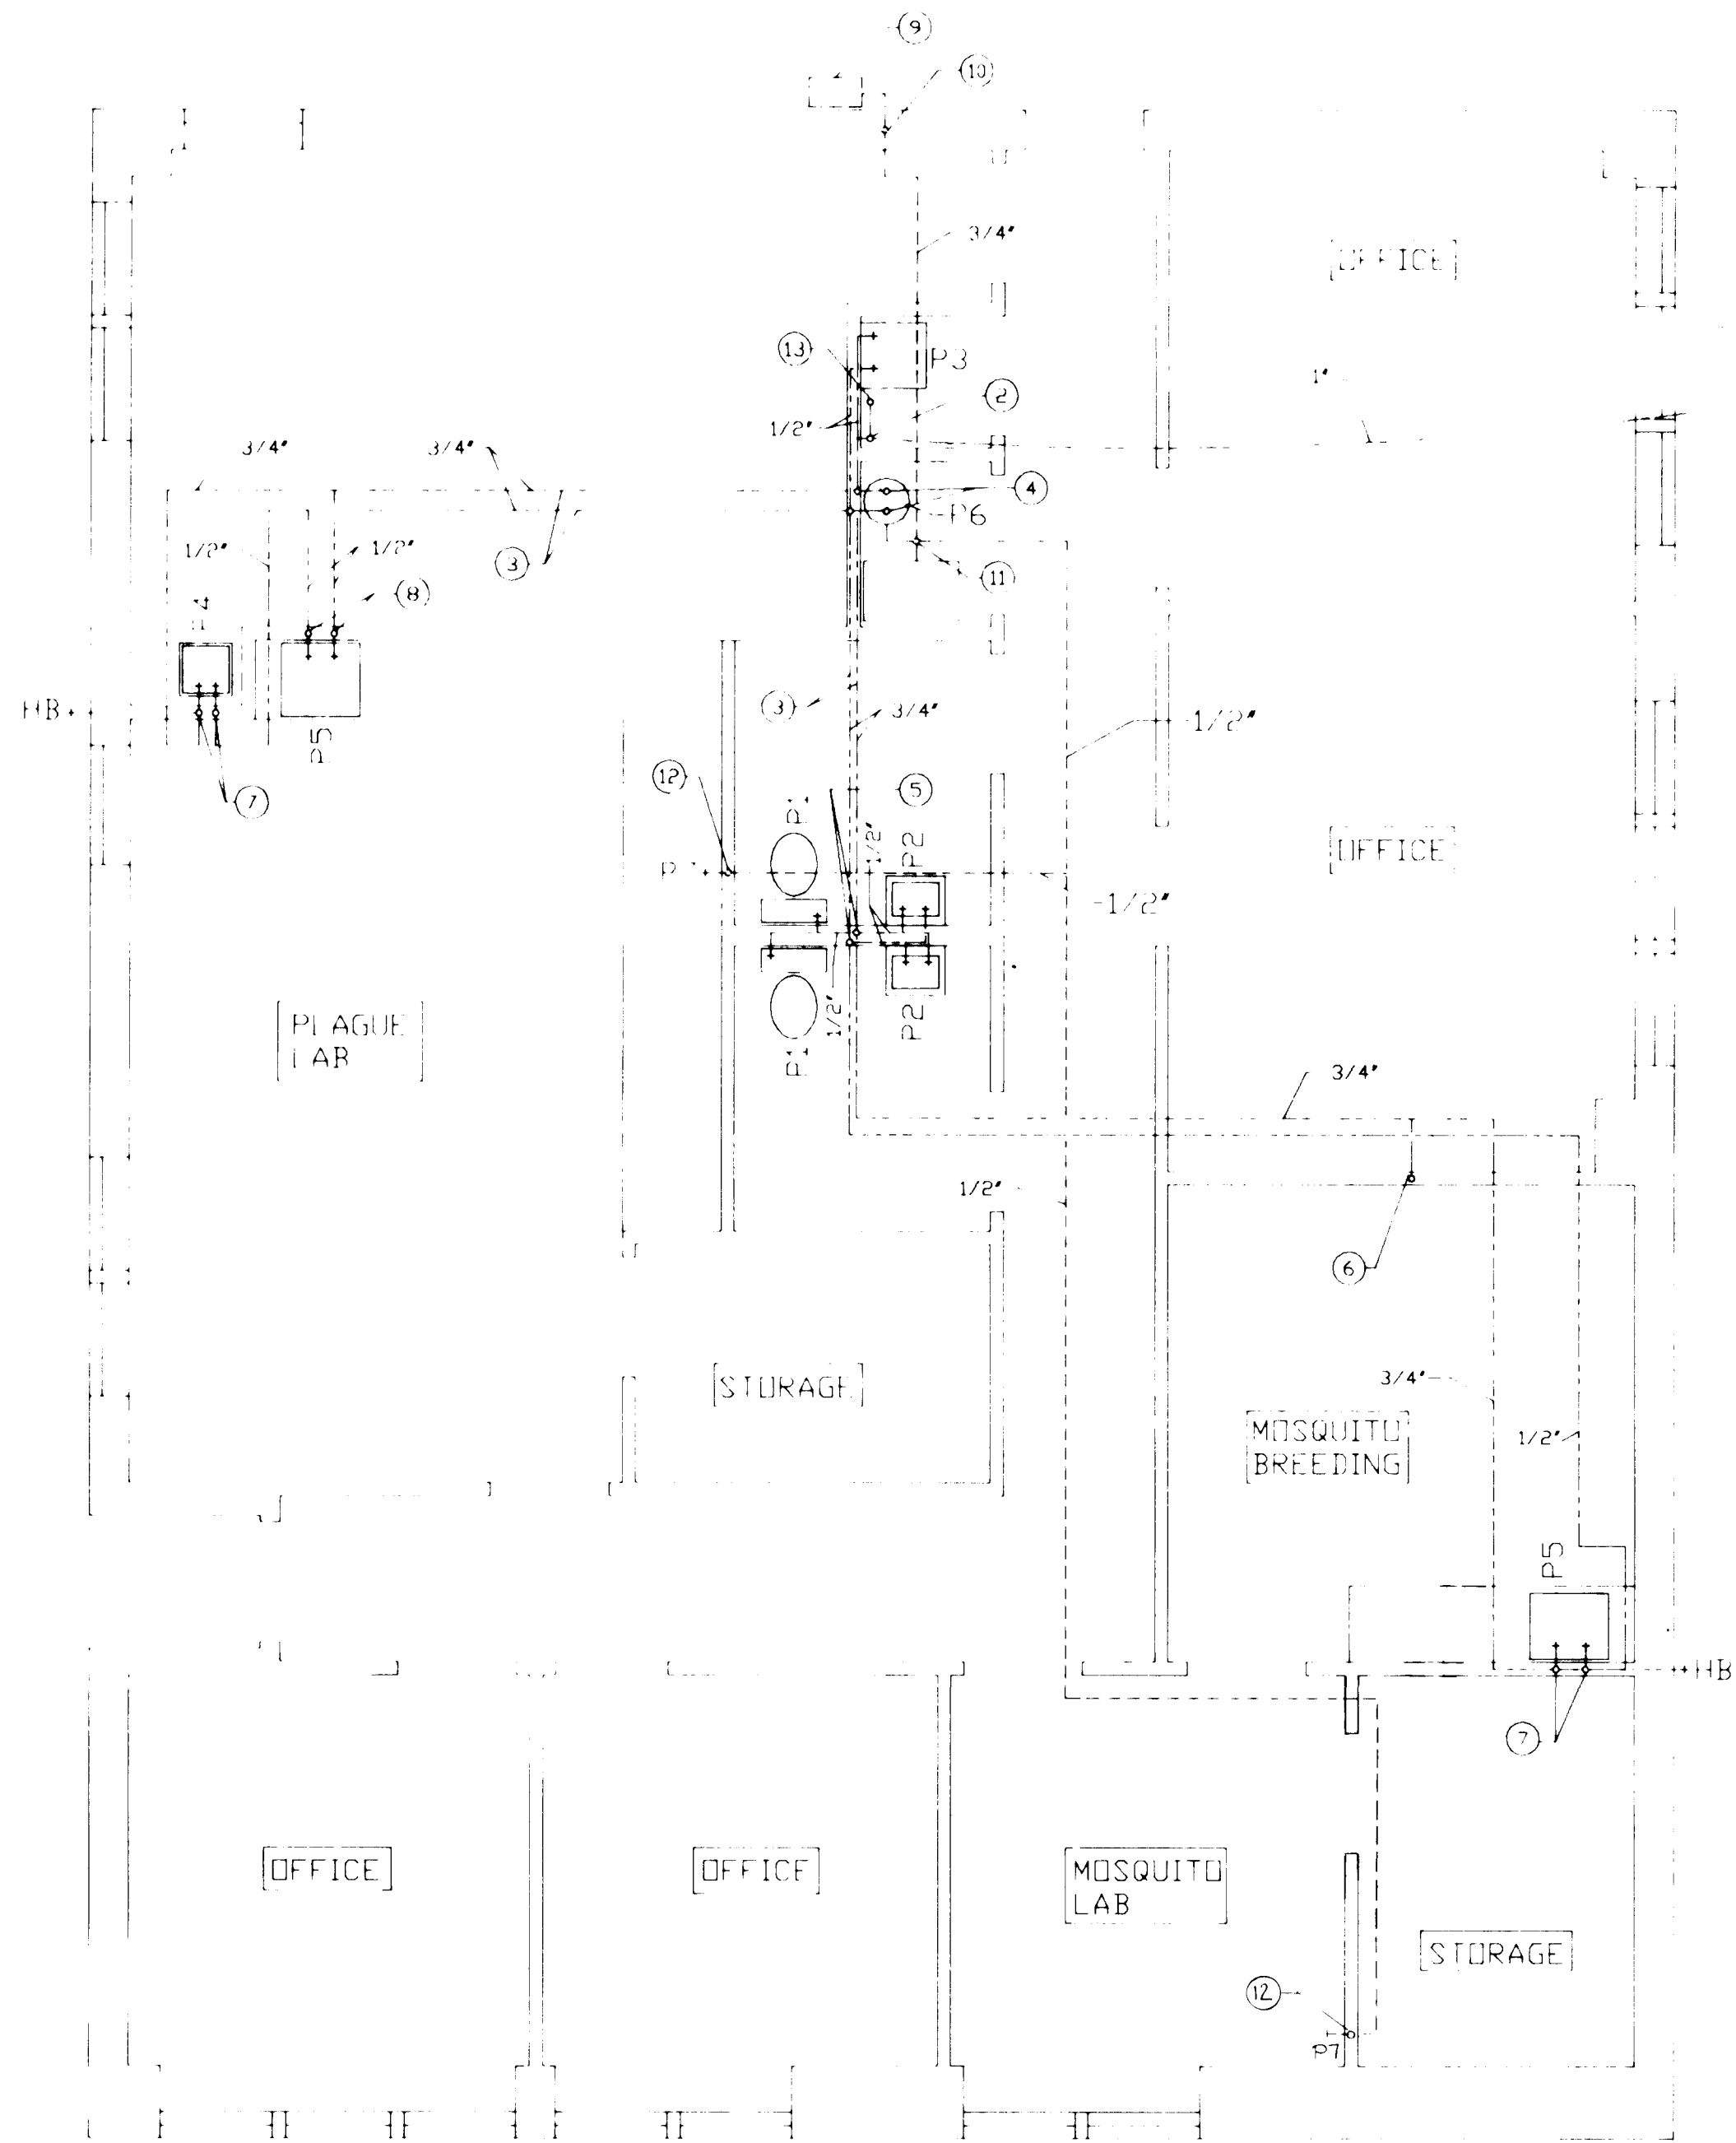



WATER & GAS PIPING PLAN

SCALE: 1/4" = 1'-0"


APPROVAL OF AS BUILT DRAWINGS
DATE 1-12-88
Russell B. Smith

 RECORD DRAWING for as built drawings
DATE 1-12-88
Russell B. Smith



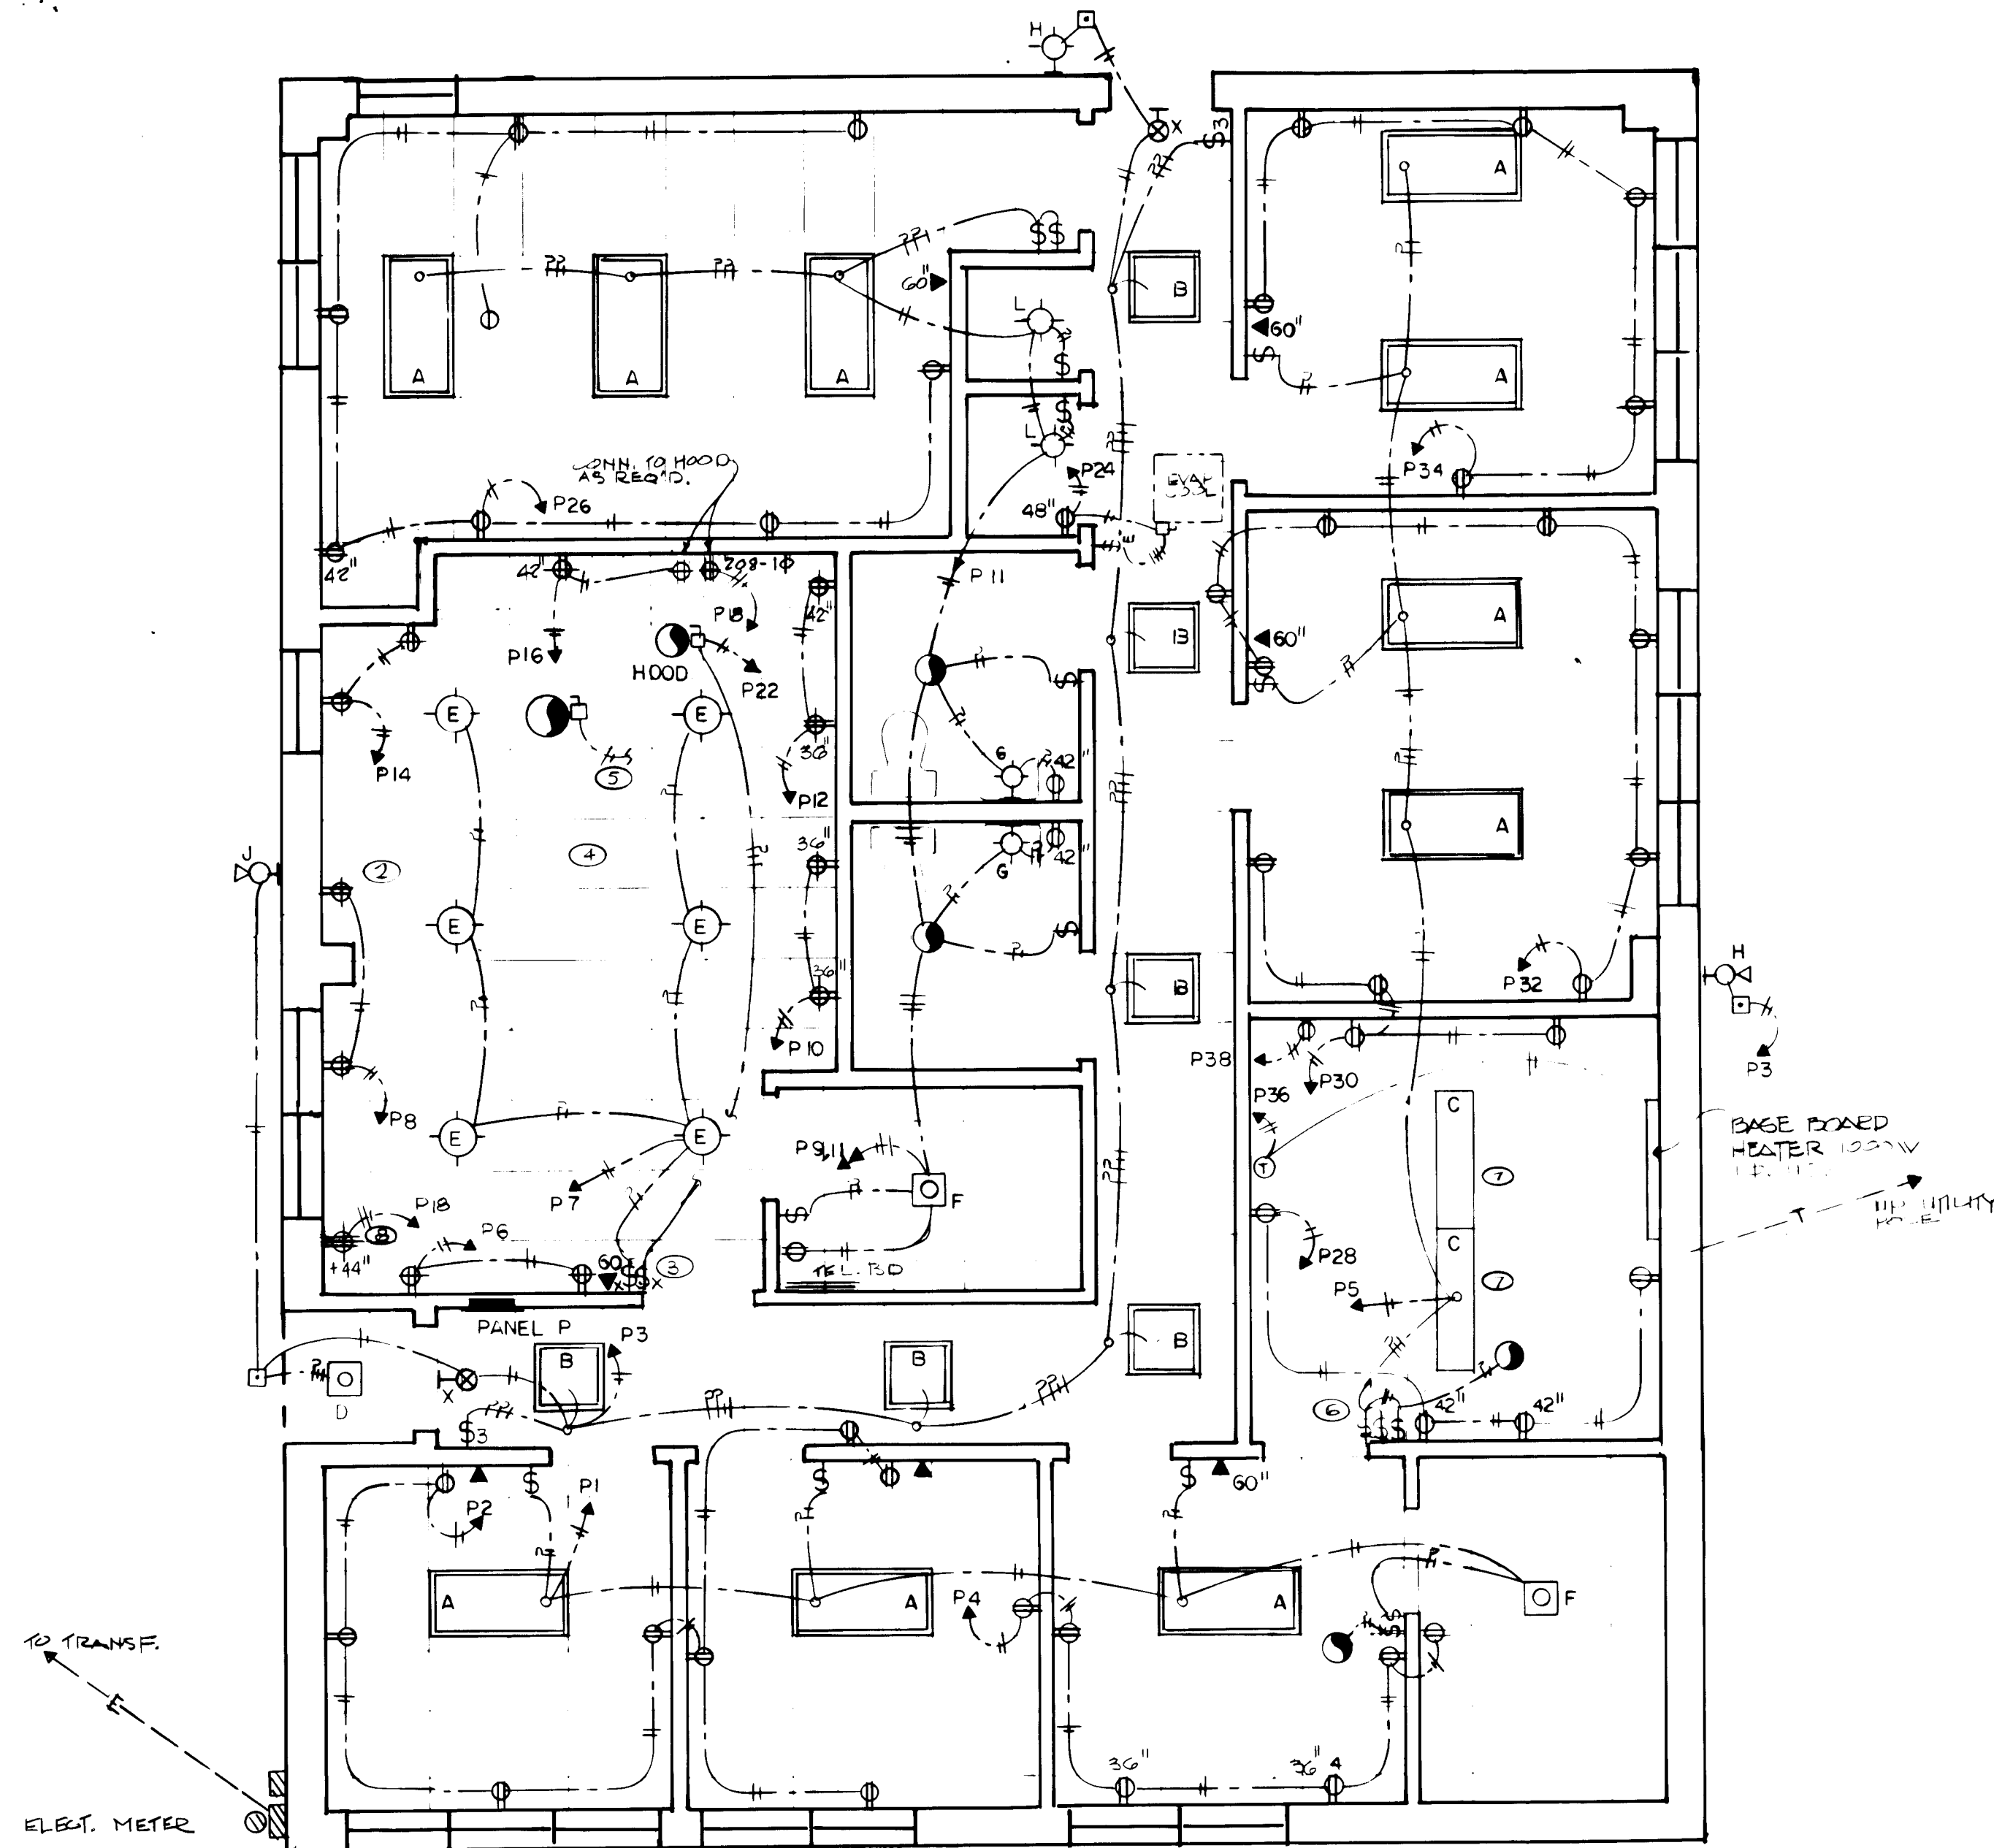


ELECTRICAL LAYOUT — LAB
1/4" = 1' 0"

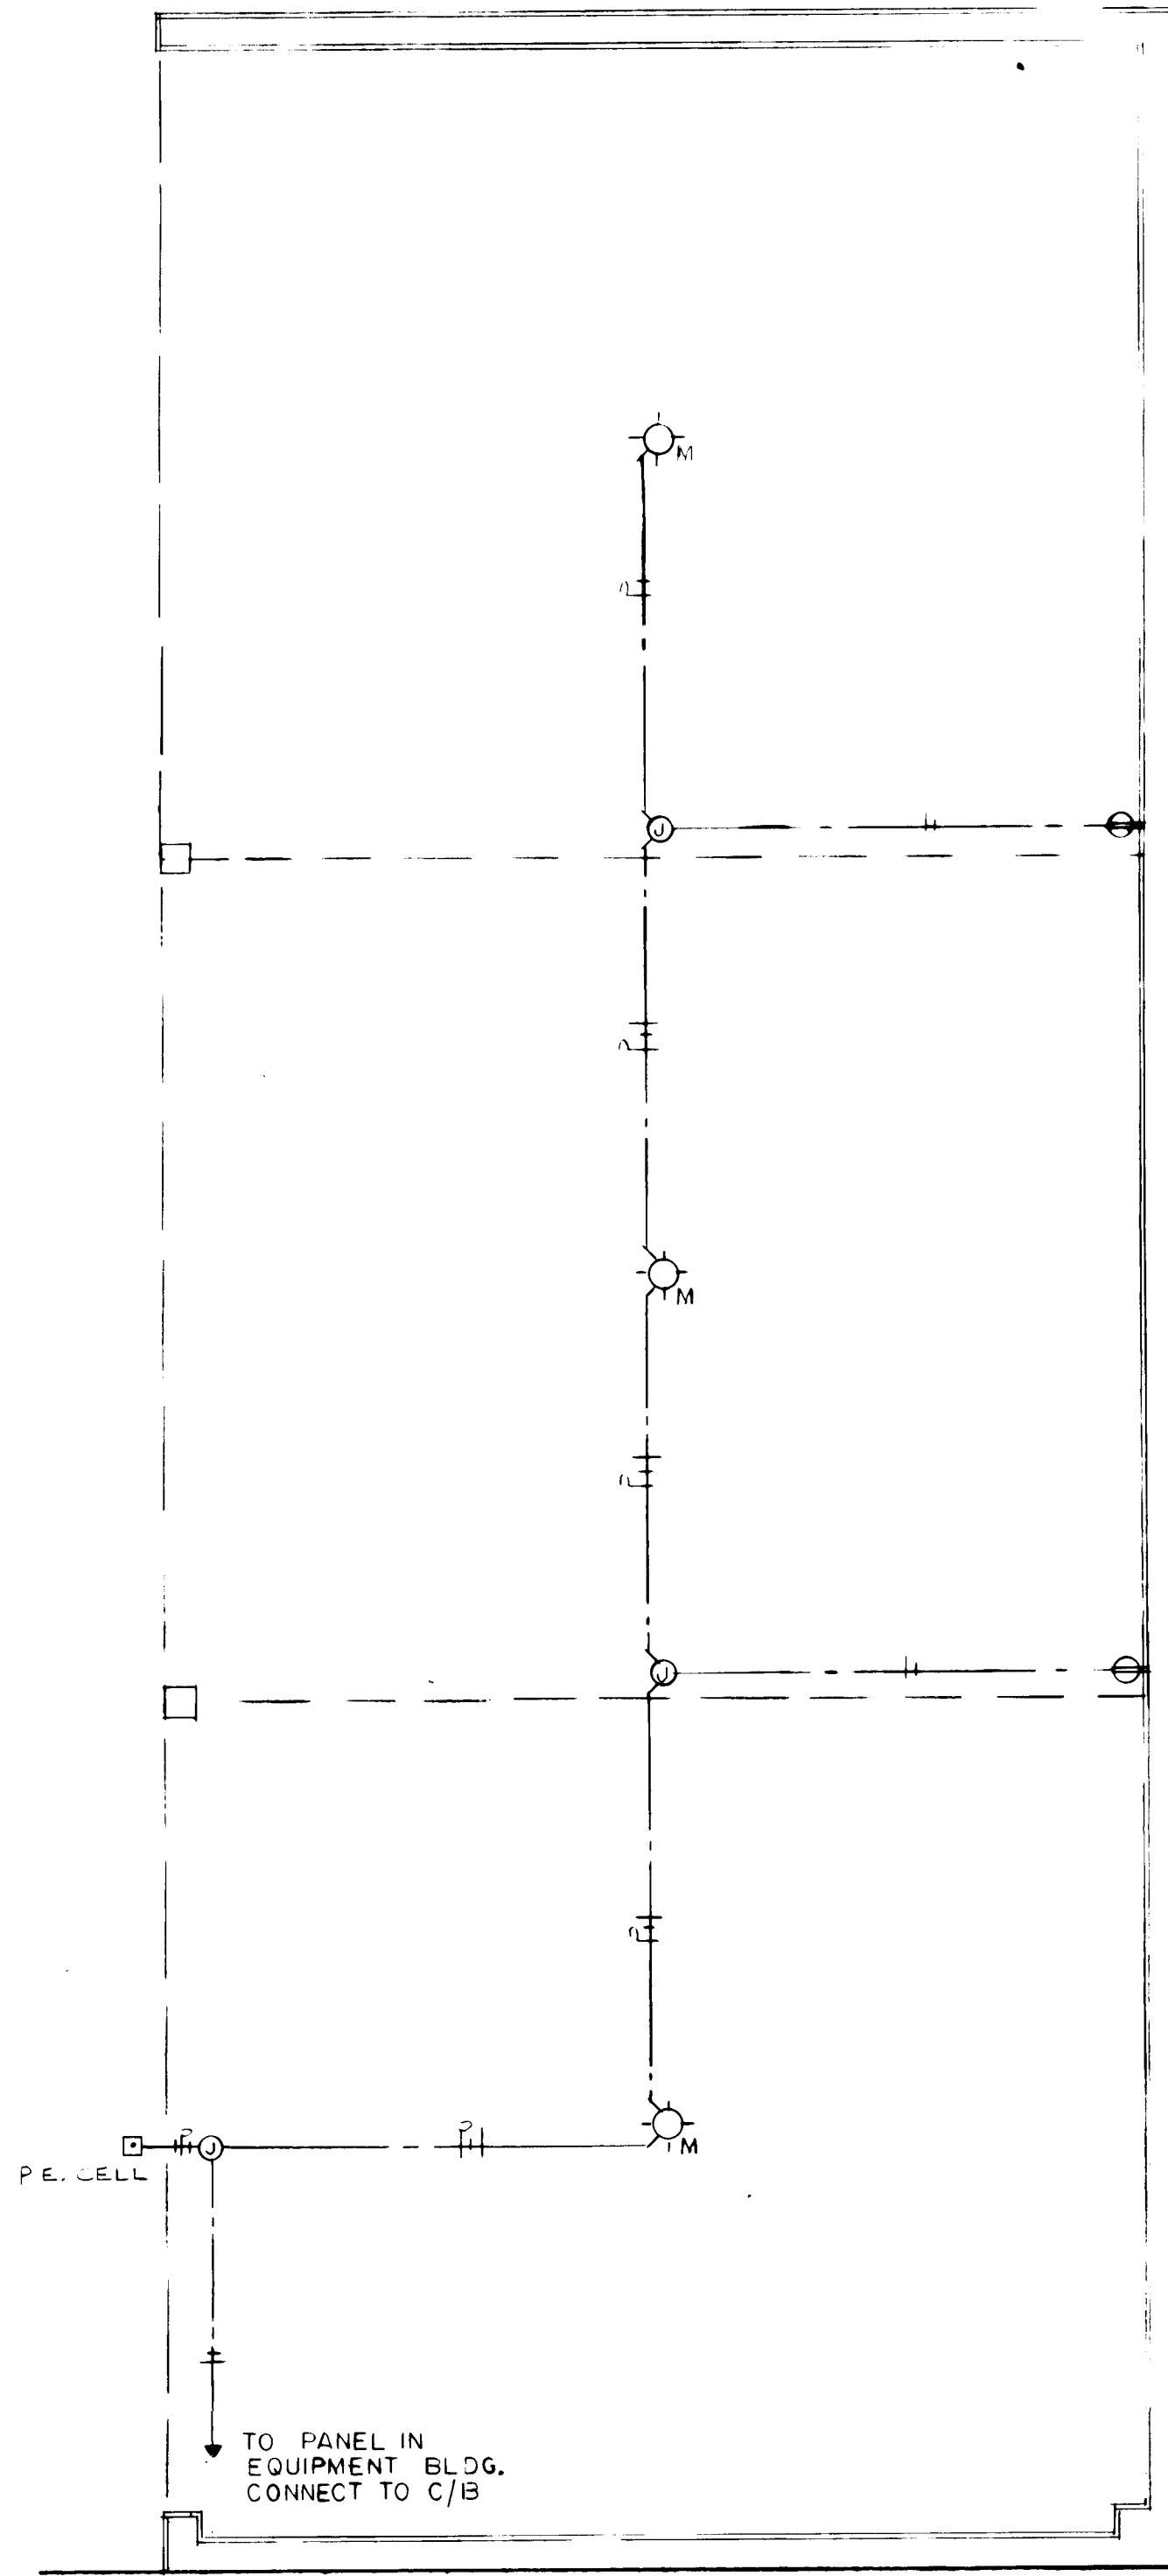

ELECTRICAL — TRUCK SHED
1/4" = 1' 0"

EX. 1000 WATT IN EQUIPMENT BLDG. EQUIPMENT BLDG. IN TRUCK SHED 2500 WATT EQUIPMENT BLDG. IN TRUCK SHED 2500 WATT

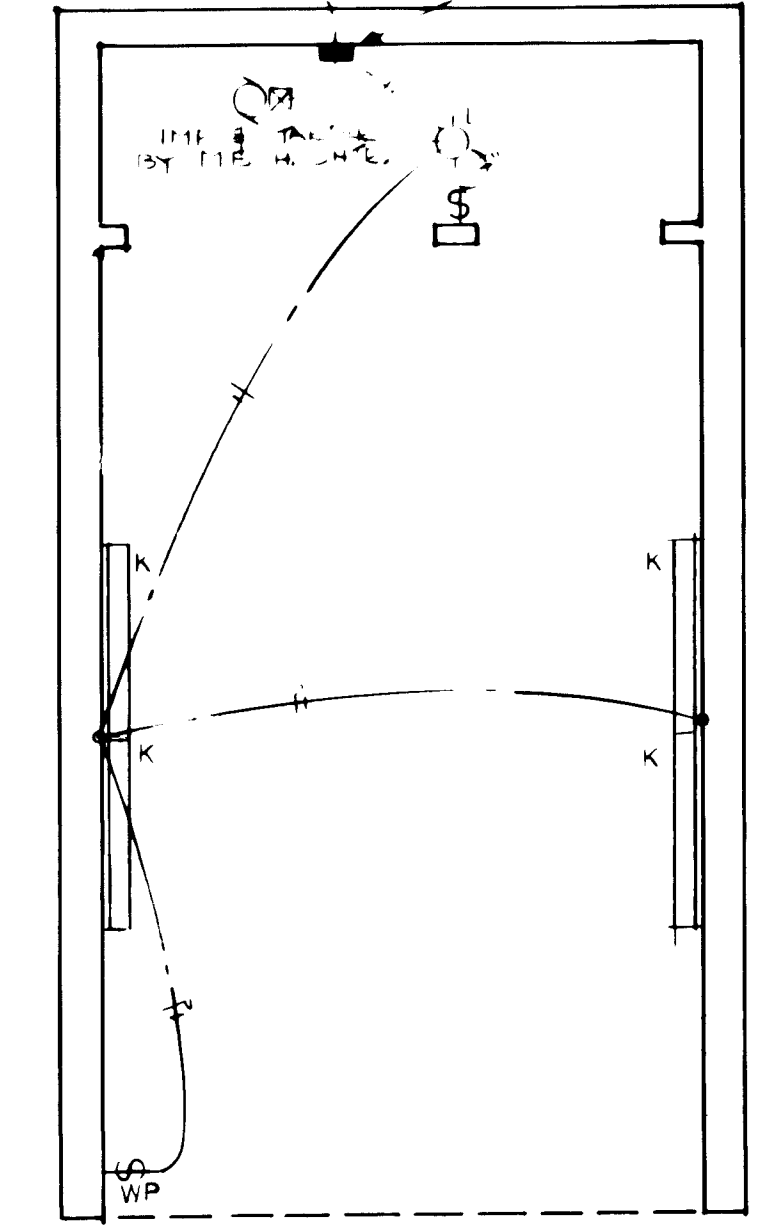

ELECTRICAL — WASH
1/4" = 1' 0"

LIGHT FIXTURES				
A	LITHONIA	#2GT-440-A12-120V	4-F40 CVX	REC. GRID
B	LITHONIA	2GS-2440-A12-120V	2-UF40 CVX	REC. GRID
C	BENJAMIN	FE-1524-4-120V/DIMBAL	2-F40 CVX	CLQ. SUKF.
D	PROGRESS	P6485	1-50W HP.	REC. CLQ.
E	APPLETON	AP-1550/AARV-15ST	1-200V IF	STEM
F	PROGRESS	P2-TG/PLG40-29	1-100V IF	REC. CLQ.
G	PROGRESS	P3030	2-75W IF	WALL 7'
H	HUBBELL	NRG-301/PC-120	1-50W HPS	WALL 10'
J	HUBBELL	PVL-01503-11120/PBT-1	1-150W HPS	WALL 11'±
K	MARCO	NP5-20ES/HP5-2EF	2-F40 CV	WALL 8'±
L	HUBBELL	VB-150	1-100W IF	CLQ. SUKF.
M	PROGRESS	P5694/P8600	1-9V PL9	CLQ. SUKF.
X	DUALITE	X2100		WALL 7'4"±

RECORD DRAWING
DATE: 10/15/86
REV: 1

ELECTRICAL PLANS
OFFICE/LAB BUILDING
TRUCK SHED
CAR WASH


MONTESSA PARK RENOVATION
FOR THE
CITY OF ALBUQUERQUE
ENVIRONMENTAL HEALTH DEPARTMENT

METRON ARCHITECTS GROUP
413 Montecito Drive NE
Albuquerque, NM 87106
505/888-8800

E 1

26 28071788
APPROVAL OF AS BUILT DRAWINGS
DATE: 1-12-88

1-12-88

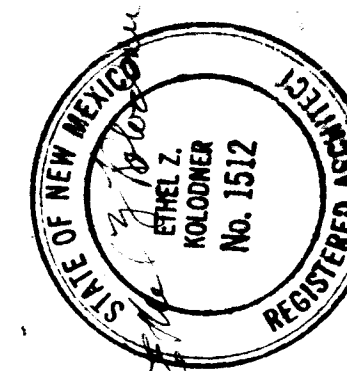


APPROVALS	DATE	APPROVALS	DATE
City Engineer	10/15/86	City Engineer	10/15/86
City Engineer	10/15/86	City Engineer	10/15/86
DATE	REVISION	BY	DATE	REVISION	BY
10/15/86	1	10/15/86	10/15/86	1	10/15/86
10/15/86	1	10/15/86	10/15/86	1	10/15/86
RECORD DRAWING
SITE PLAN
LANDSCAPE PLAN
ROOF PLAN

MONTESSA PARK RENOVATION
FOR THE
CITY OF ALBUQUERQUE
ENVIRONMENTAL HEALTH DEPARTMENT

METRON ARCHITECTS GROUP
413 Montebello Drive NE
Albuquerque, NM 87108
505/265-8880

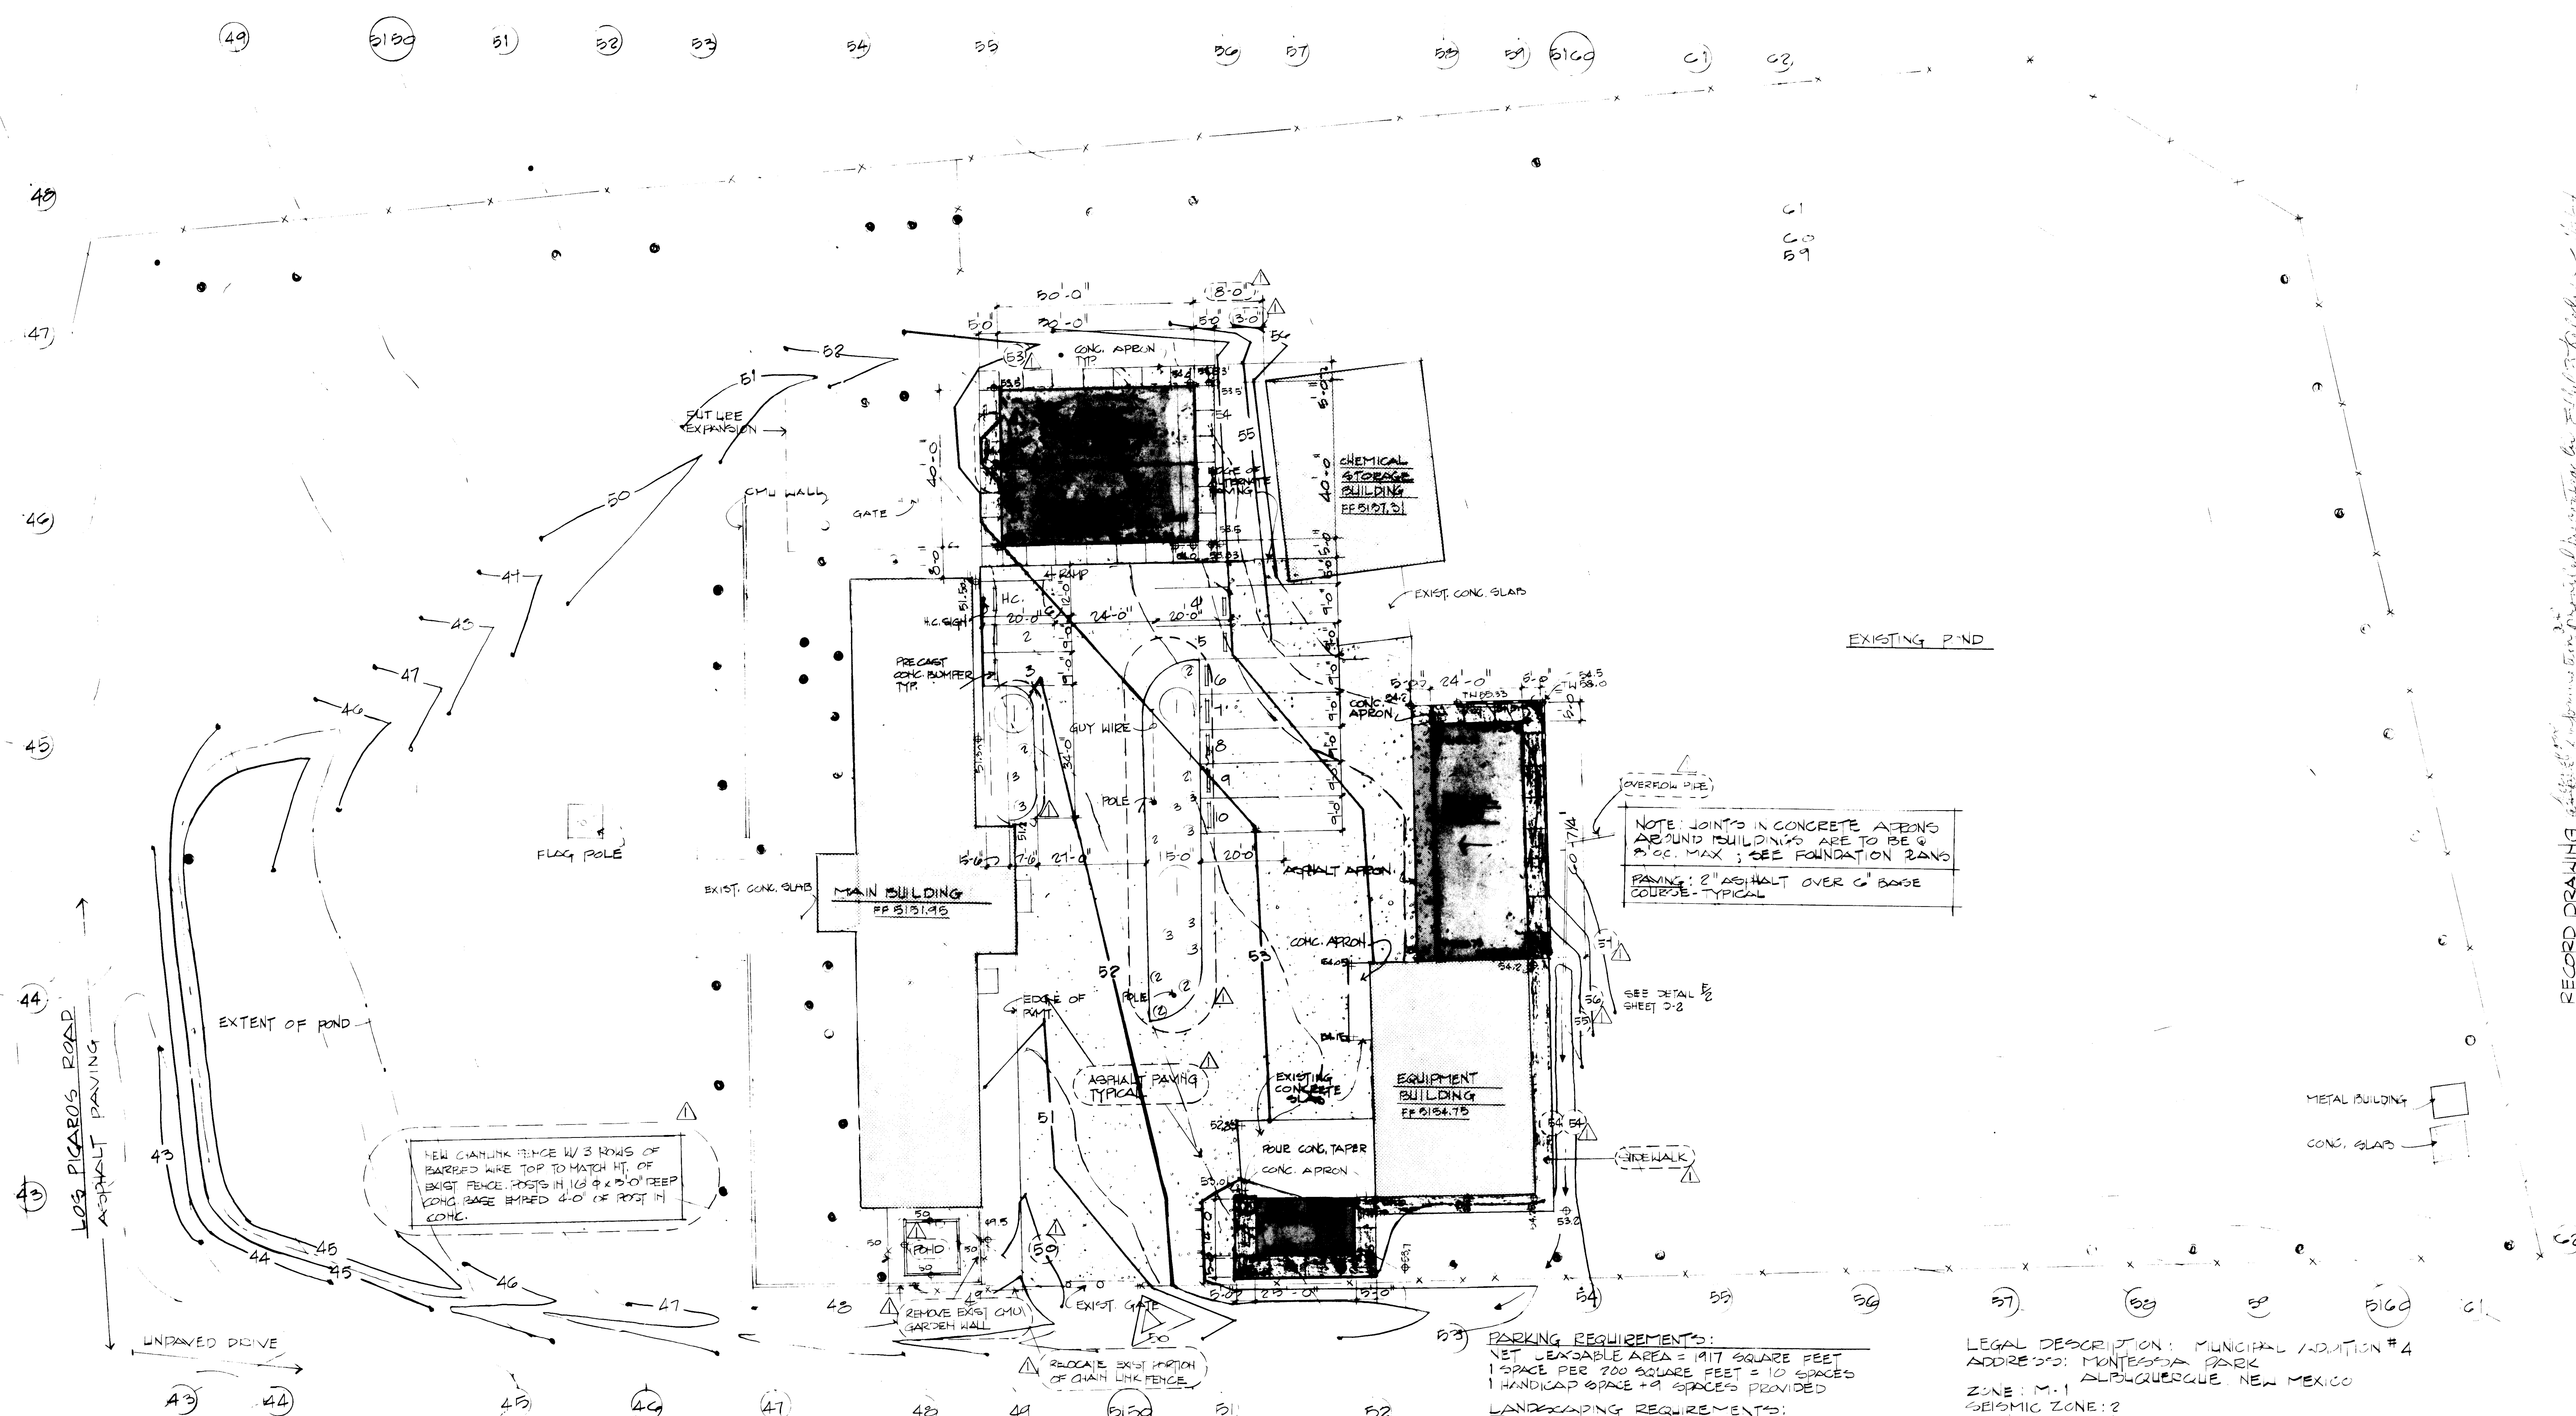

- SYMBOL KEY**
- | | | | |
|-----|--|-----|------------------|
| 1 | RUSSIAN OLIVE, 1 1/2" CALIPER | XX | EXISTING CONTOUR |
| 2 | CHAMISA, 5 GALLON | XX | NEW CONTOUR |
| 3 | GRAY SANTOLINA, 5 GALLON | • | UTILITY POLE |
| 4 | ADDED LANDSCAPING FOR ALTERNATE PAVING | --- | CHAIN LINK FENCE |
| 5 | EXISTING TREES & BUSHES | | |
| 6 | ASPHALT PAVING | | |
| 7 | ADDITIVE ALTERNATE; ASPHALT PAVING | | |
| 8 | NEW CONCRETE APRON | | |
| 9 | EXISTING CONCRETE SLAB OR APRON | | |
| 10 | | | |
| 11 | | | |
| 12 | | | |
| 100 | | | |

PARKING REQUIREMENTS:
NET EXPOSABLE AREA = 1917 SQUARE FEET
1 SPACE PER 200 SQUARE FEET = 10 SPACES
1 HANDICAP SPACE + 9 SPACES PROVIDED

LANDSCAPING REQUIREMENTS:
PAVED AREA = 4,416 SQUARE FEET
7 1/2" X 4,416 = 33,120 SQUARE FEET
325 SQUARE FEET PROVIDED
ALTERNATE PAVED AREA = 7,401 SQUARE FEET
7 1/2" X 7,401 = 55,508 SQUARE FEET
5550 SQUARE FEET PROVIDED

LEGAL DESCRIPTION: MUNICIPAL ADDITION #4
ADDRESS: MONTESSA PARK
ALBUQUERQUE, NEW MEXICO

ZONE: M-1
SEISMIC ZONE: 2
GROUP: OFFICE/LABORATORY - B-2
TRUCK SHED - B-1, CAR WASH - B-1
CHEMICAL STORAGE BUILDING - B-2
EQUIPMENT BUILDING - H-4, MAIN BUILDING - H-2
OFFICE/LABORATORY - V-1
TRUCK SHED - V-1 W/ 1 HR. WALL OCCUPANCY SEPARATION
CAR WASH - V-1

TYPE: OFFICE/LABORATORY - 2,000 SQUARE FEET
TRUCK SHED - 1,400 SQUARE FEET
CAR WASH - 300 SQUARE FEET

AREA: OFFICE/LABORATORY - 2,000 SQUARE FEET
TRUCK SHED - 1,400 SQUARE FEET
CAR WASH - 300 SQUARE FEET




SOIL BEARING: 1,500 P.S.F. & OFFICE/LABORATORY
1,000 P.S.F. & TRUCK SHED & CAR WASH

CONCRETE: 3000 PSI
STEEL: F_y = 36 KSI
WIND LOAD: 25 PSF
ROOF LIVE LOAD: 20 PSF

26 28070488

1-12-88

NORTH SCALE: 1" = 20'

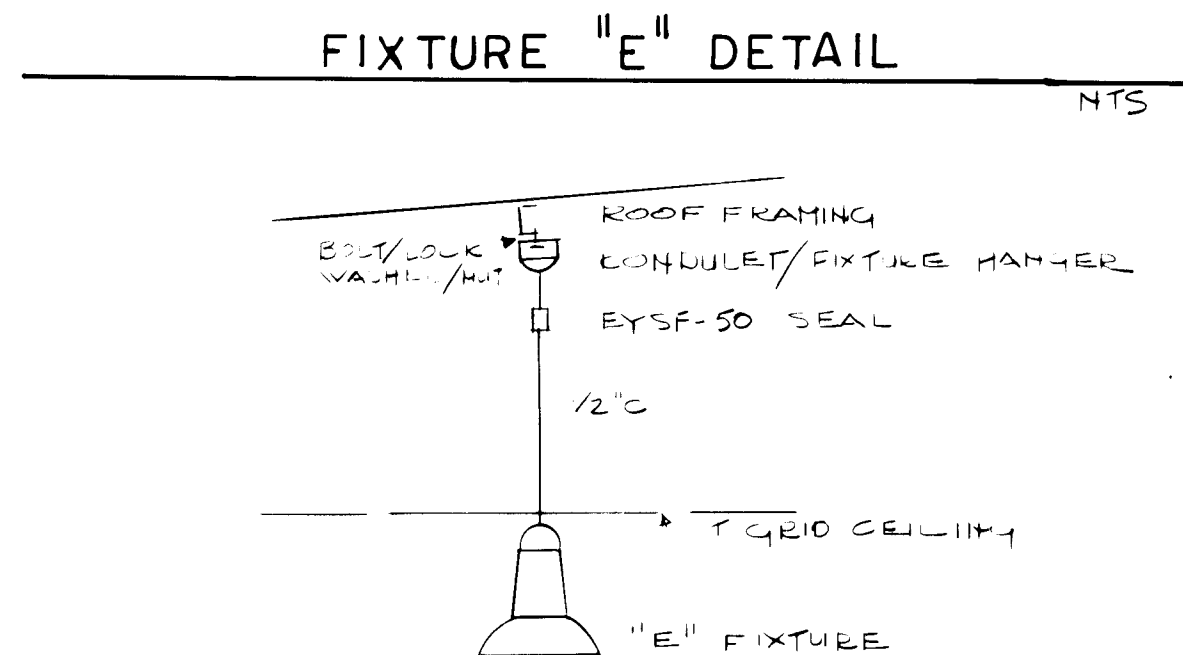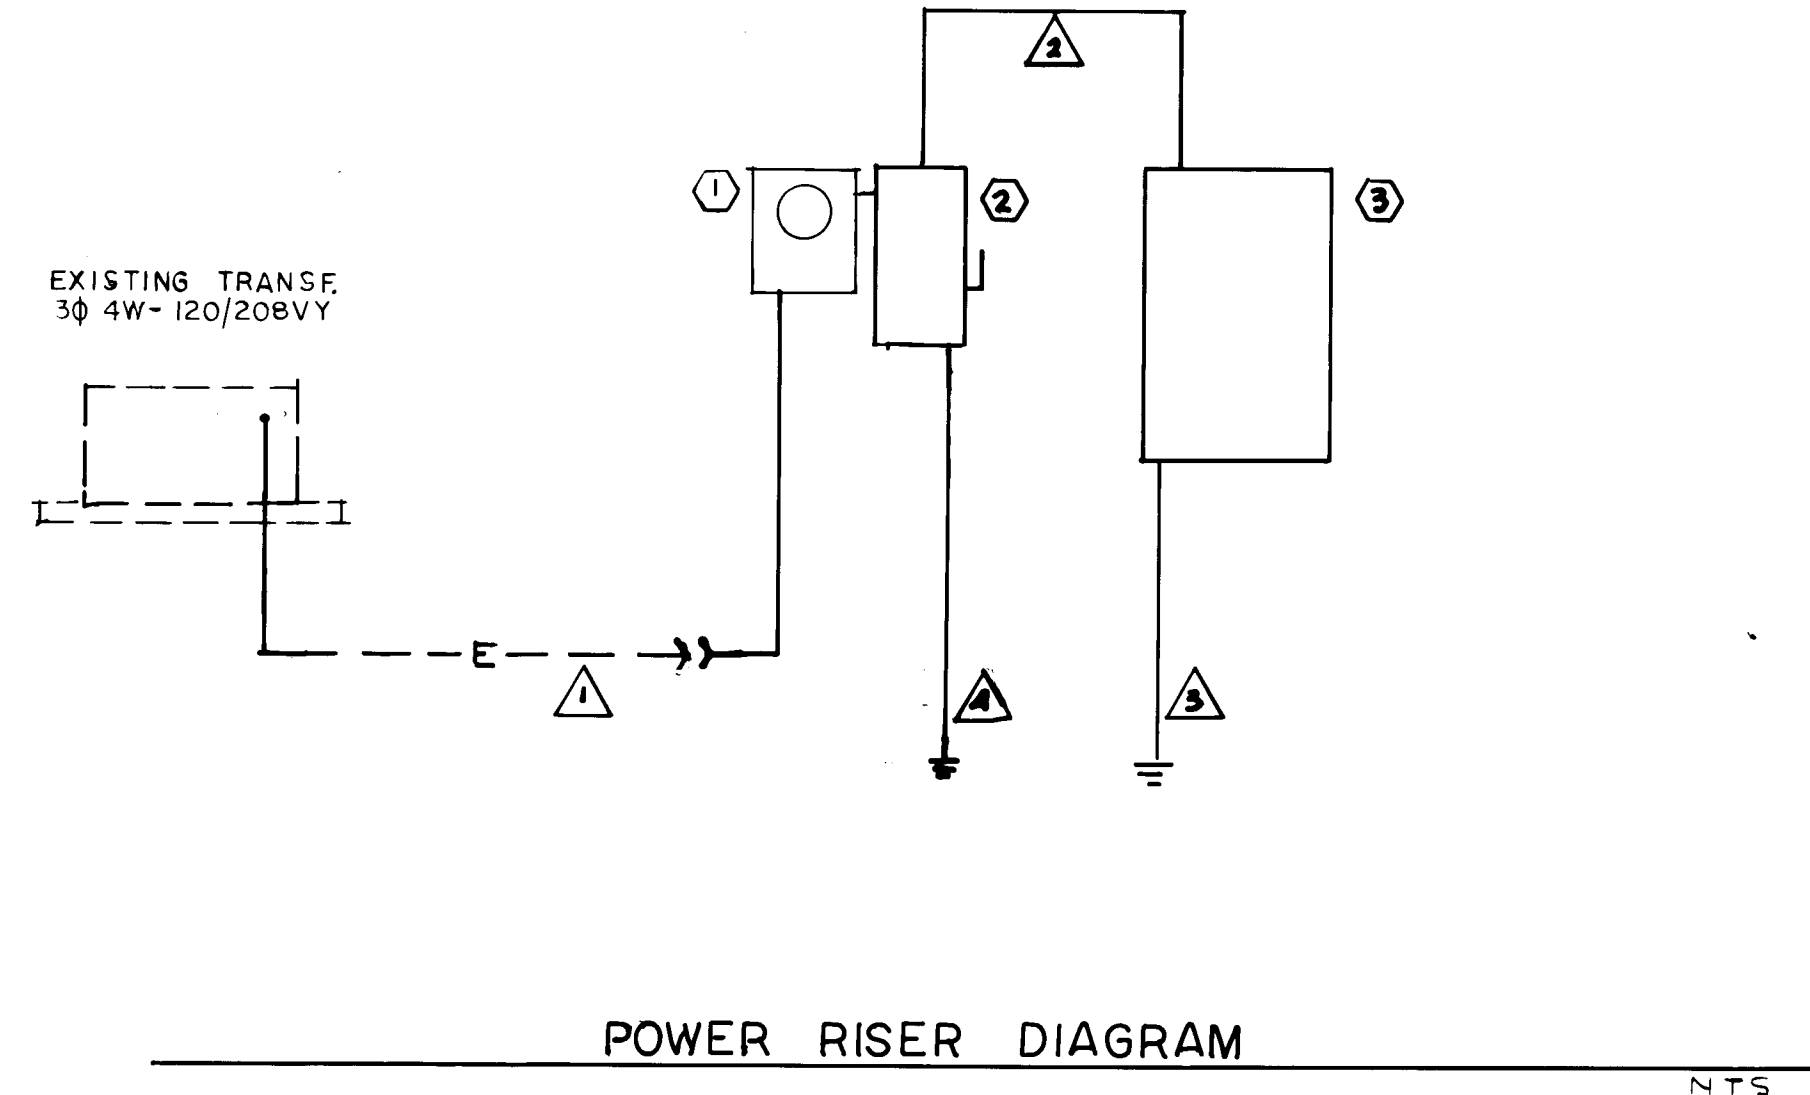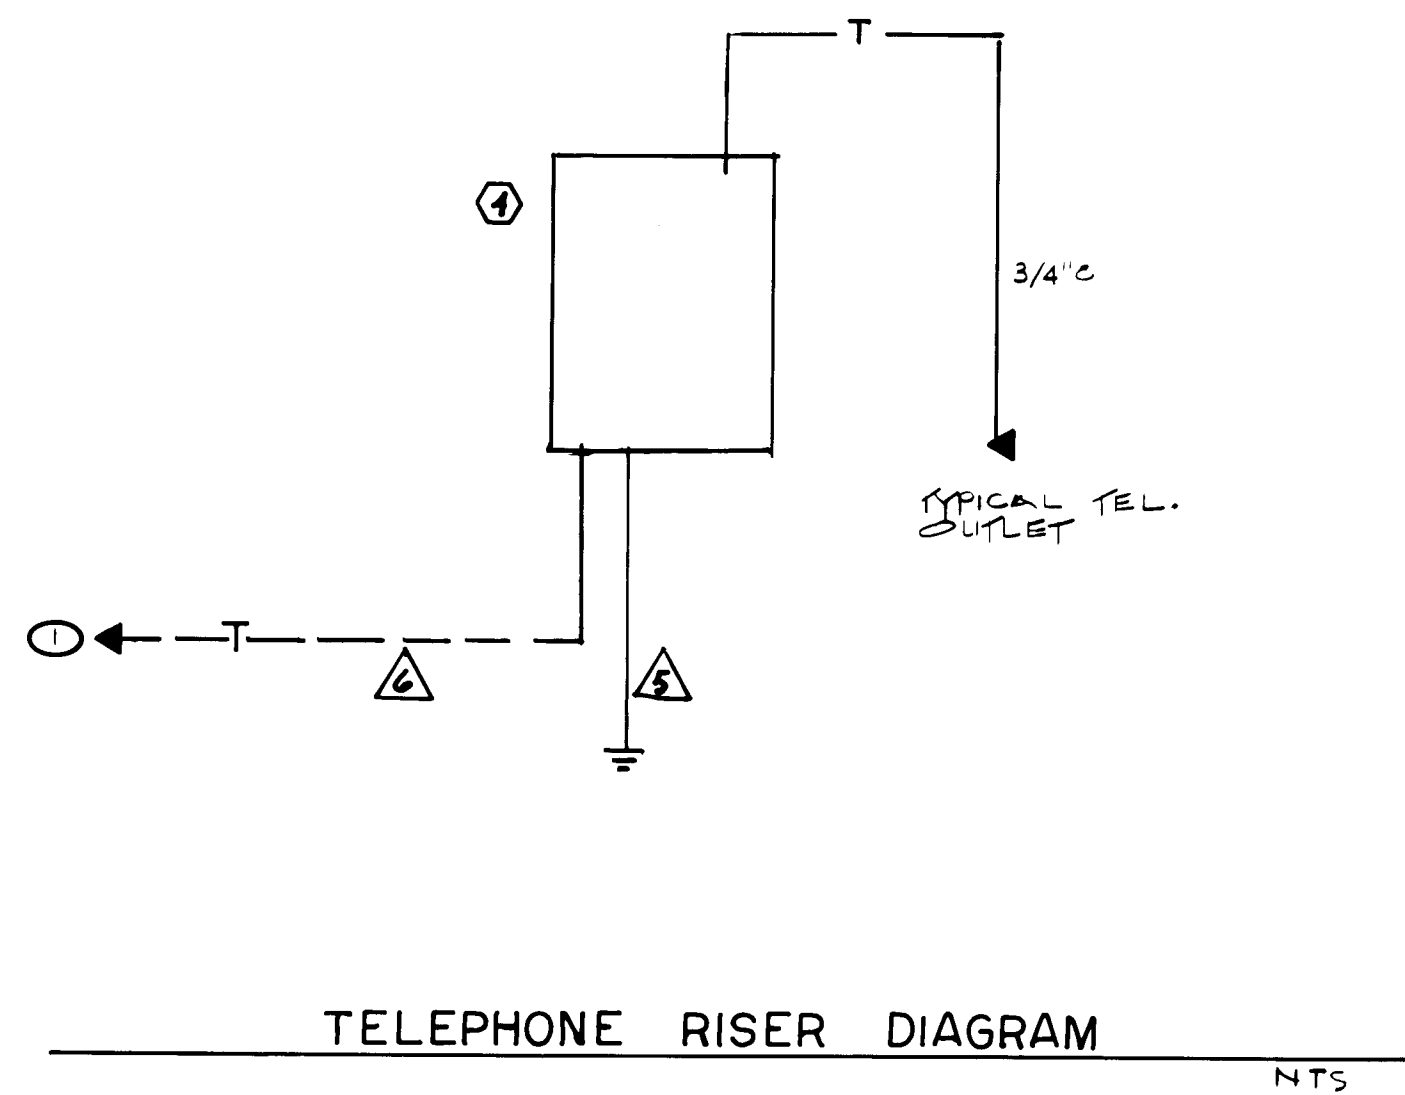

PANEL P SCHEDULE	
1' LTS - OFFICES/SR.	20
3 - H/L/O/SIDE	20
5 - OFF/MOS. LAB	20
7 - PLQ. LAB	20
9 - RBMS/SR	20
11 - COFF/FIICH	20
13 SPACE	20
15 "	20
17 "	20
19 "	20
21 "	20
23 SPACE	20
25 "	20
27 "	20
29 "	20
31 "	20
33 "	20
35 "	20
37 "	20
39 "	20

- ### ELECTRICAL EQUIPMENT
- ELECTRIC METER, 30, 200A, PER P.A.M. DWG. 75-19-11.4
 - MAIN DISCONNECT SWITCH, 4W, 5/N, 240V, 100A, NEMA-3R, HEAVY DUTY TYPE, FUSED. USE TYPE "FRN-100" FUSES.
INSTALL SJ-D, TYPE #J9200-9A, SURGE PROTECTOR INTO DISCONNECT ON PANEL P.
 - PANEL P
300W, 120-208VY, 200A BUS, M.L.D., FLUSH MTD. SJ-D, TYPE "QQ" WITH 10,000AIC BREAKERS. SEE PANEL SCHEDULE.
 - TELEPHONE TERMINAL BOARD, 3"x4"x3/4" PLYWOOD.
4 #1-TW-LU-2"U.
4 #1-TW-LU-2"U.
1 #4-LU TO C.W.P.
1 #4-LU-1"U. TO GND. RND 5/8"x8" CU-CLAD
1 #4-LU TO C.W.P.

ELECTRICAL DATA

1. ESTIMATED NEW CONNECTED LOAD:	21 KW
ESTIMATED NEW DEMAND LOAD:	10 KW

- ### KEYED NOTES
- 1" C. OUT TO AND UP UTILITY POLE. VERIFY EXACT LOCATION.
 - APPLETON TYPE #EHR-56/EHRA-56 RECESSED FLUSH IN WALL TYPICAL OF ALL. CONTRACTOR TO FURNISH 3 EACH, APPLETON #EHR-56 PLUGS.
 - APPLETON #EFS-175-11, 1P SWITCH FLUSH IN WALL.
 - PLAGUE LAB AREA WIRED PER N.E.C. ART. 501 FOR CLASS I DIVISION II.
 - INTERLOCK EXHAUST FAN WITH FURNACE. PROVIDE RELAY AS REQUIRED.
 - AT THIS LOCATION INSTALL ONE EACH TIMER, FLUORESCENT DIMMER AND 1P SWITCH:
1 -TORX #72002-L-FL1
1 -LUTRON #FD-12 (FLUOR. DIMMER)
1 -1P SW
 - INSTALL DIMMING FLUORESCENT BALLAST IN FIXTURE TYPE "C". (ADVANCE #240-H OR EQUAL)
 - APPLETON #EHR-3023/CPP-3023C

SYMBOLS

SWITCH, 1P, 20A SPEC. GRADE	UP 52"
SWITCH, 2P, 20A SPEC. GRADE	UP 52"
SWITCH, EXPLOSION PROOF	UP 52"
SWITCH, 3W, 20A, SPEC. GRADE	UP 52"
DUPLEX OUTLET, 15A, SPEC. GRADE	UP 18"
OUTLET, EXPLOSION PROOF	UP 18"
JUNCTION BOX	
EXIT LIGHT	
EMERGENCY LIGHT	
LIGHT FIXTURE, CEILING SURFACE MTD.	
LIGHT FIXTURE, WALL MTD.	
LIGHT FIXTURE, RECESSED IN CEILING	
LIGHT FIXTURE, FLUSH IN CLG. GRID	
DISCONNECT SWITCH, FUSED	
MOTOR STARTER/CONTACTOR	
CIRCUIT BREAKER PANEL	
TELEPHONE TERMINAL BOARD	
TELEPHONE OUTLET	UP 18"
PHOTO CELL	
CONDUIT AND WIRE IN WALL AND CEILING	
CONDUIT AND WIRE UNDERGROUND	
CONDUIT AND WIRE HOME RUN TO PANEL	
ELECTRICAL CONDUIT	
TELEPHONE CONDUIT	
DUPLEX OUTLET FLUSH IN CEILING	

- ### ELECTRICAL NOTES
- CONTRACTOR SHALL VERIFY THE EXACT LOCATIONS AND TYPE OF EQUIPMENT, CONNECTIONS AND CONTROLS REQUIRED FOR ALL MECHANICAL AND PLUMBING EQUIPMENT. THEN PROVIDE ALL LABOR, MATERIALS AND CONTROLS TO MAKE A COMPLETE AND OPERATIONAL SYSTEM. PROVIDE ALL TESTING AS MAY BE REQUIRED.
 - CONTRACTOR IS REQUIRED TO INSTALL, CONNECT, FURNISH MATERIALS AND MAKE OPERATIONAL THOSE ITEMS NOT SHOWN OR IMPLIED ON THE CONSTRUCTION DRAWINGS, BUT ARE REQUIRED UNDER OTHER SECTIONS OF THE SPECIFICATIONS AND DRAWINGS.
 - DO NOT SCALE DRAWINGS FOR EXACT LOCATIONS. USE ONLY THE ARCHITECTURAL DIMENSIONS.
 - ALL MOTORS AND MECHANICAL EQUIPMENT SHALL BE CONNECTED WITH FLEX CONDUIT. USE WEATHERPROOF FLEX IN WET OR DAMP LOCATIONS.
 - ANY DISCREPANCIES NOTED ON THE DRAWINGS OR IN THE SPECIFICATIONS SHALL BE BROUGHT TO THE ATTENTION OF THE ARCHITECT, FOR RESOLUTION PRIOR TO INSTALLATION OF THAT SPECIFIED EQUIPMENT.
 - THE ELECTRICAL LAYOUT IS DIAGRAMMATICAL ONLY. THE CONTRACTOR MAY VARY THE BRANCH CIRCUIT WIRING AS NECESSARY TO MEET ACTUAL FIELD CONSTRUCTION REQUIREMENTS.

26 28071888

1-12-58


RECORD DRAWING

ELECTRICAL NOTES

ELECTRICAL SCHEDULE


POWER RISER DIAGRAM

TELEPHONE RISER DIAGRAM

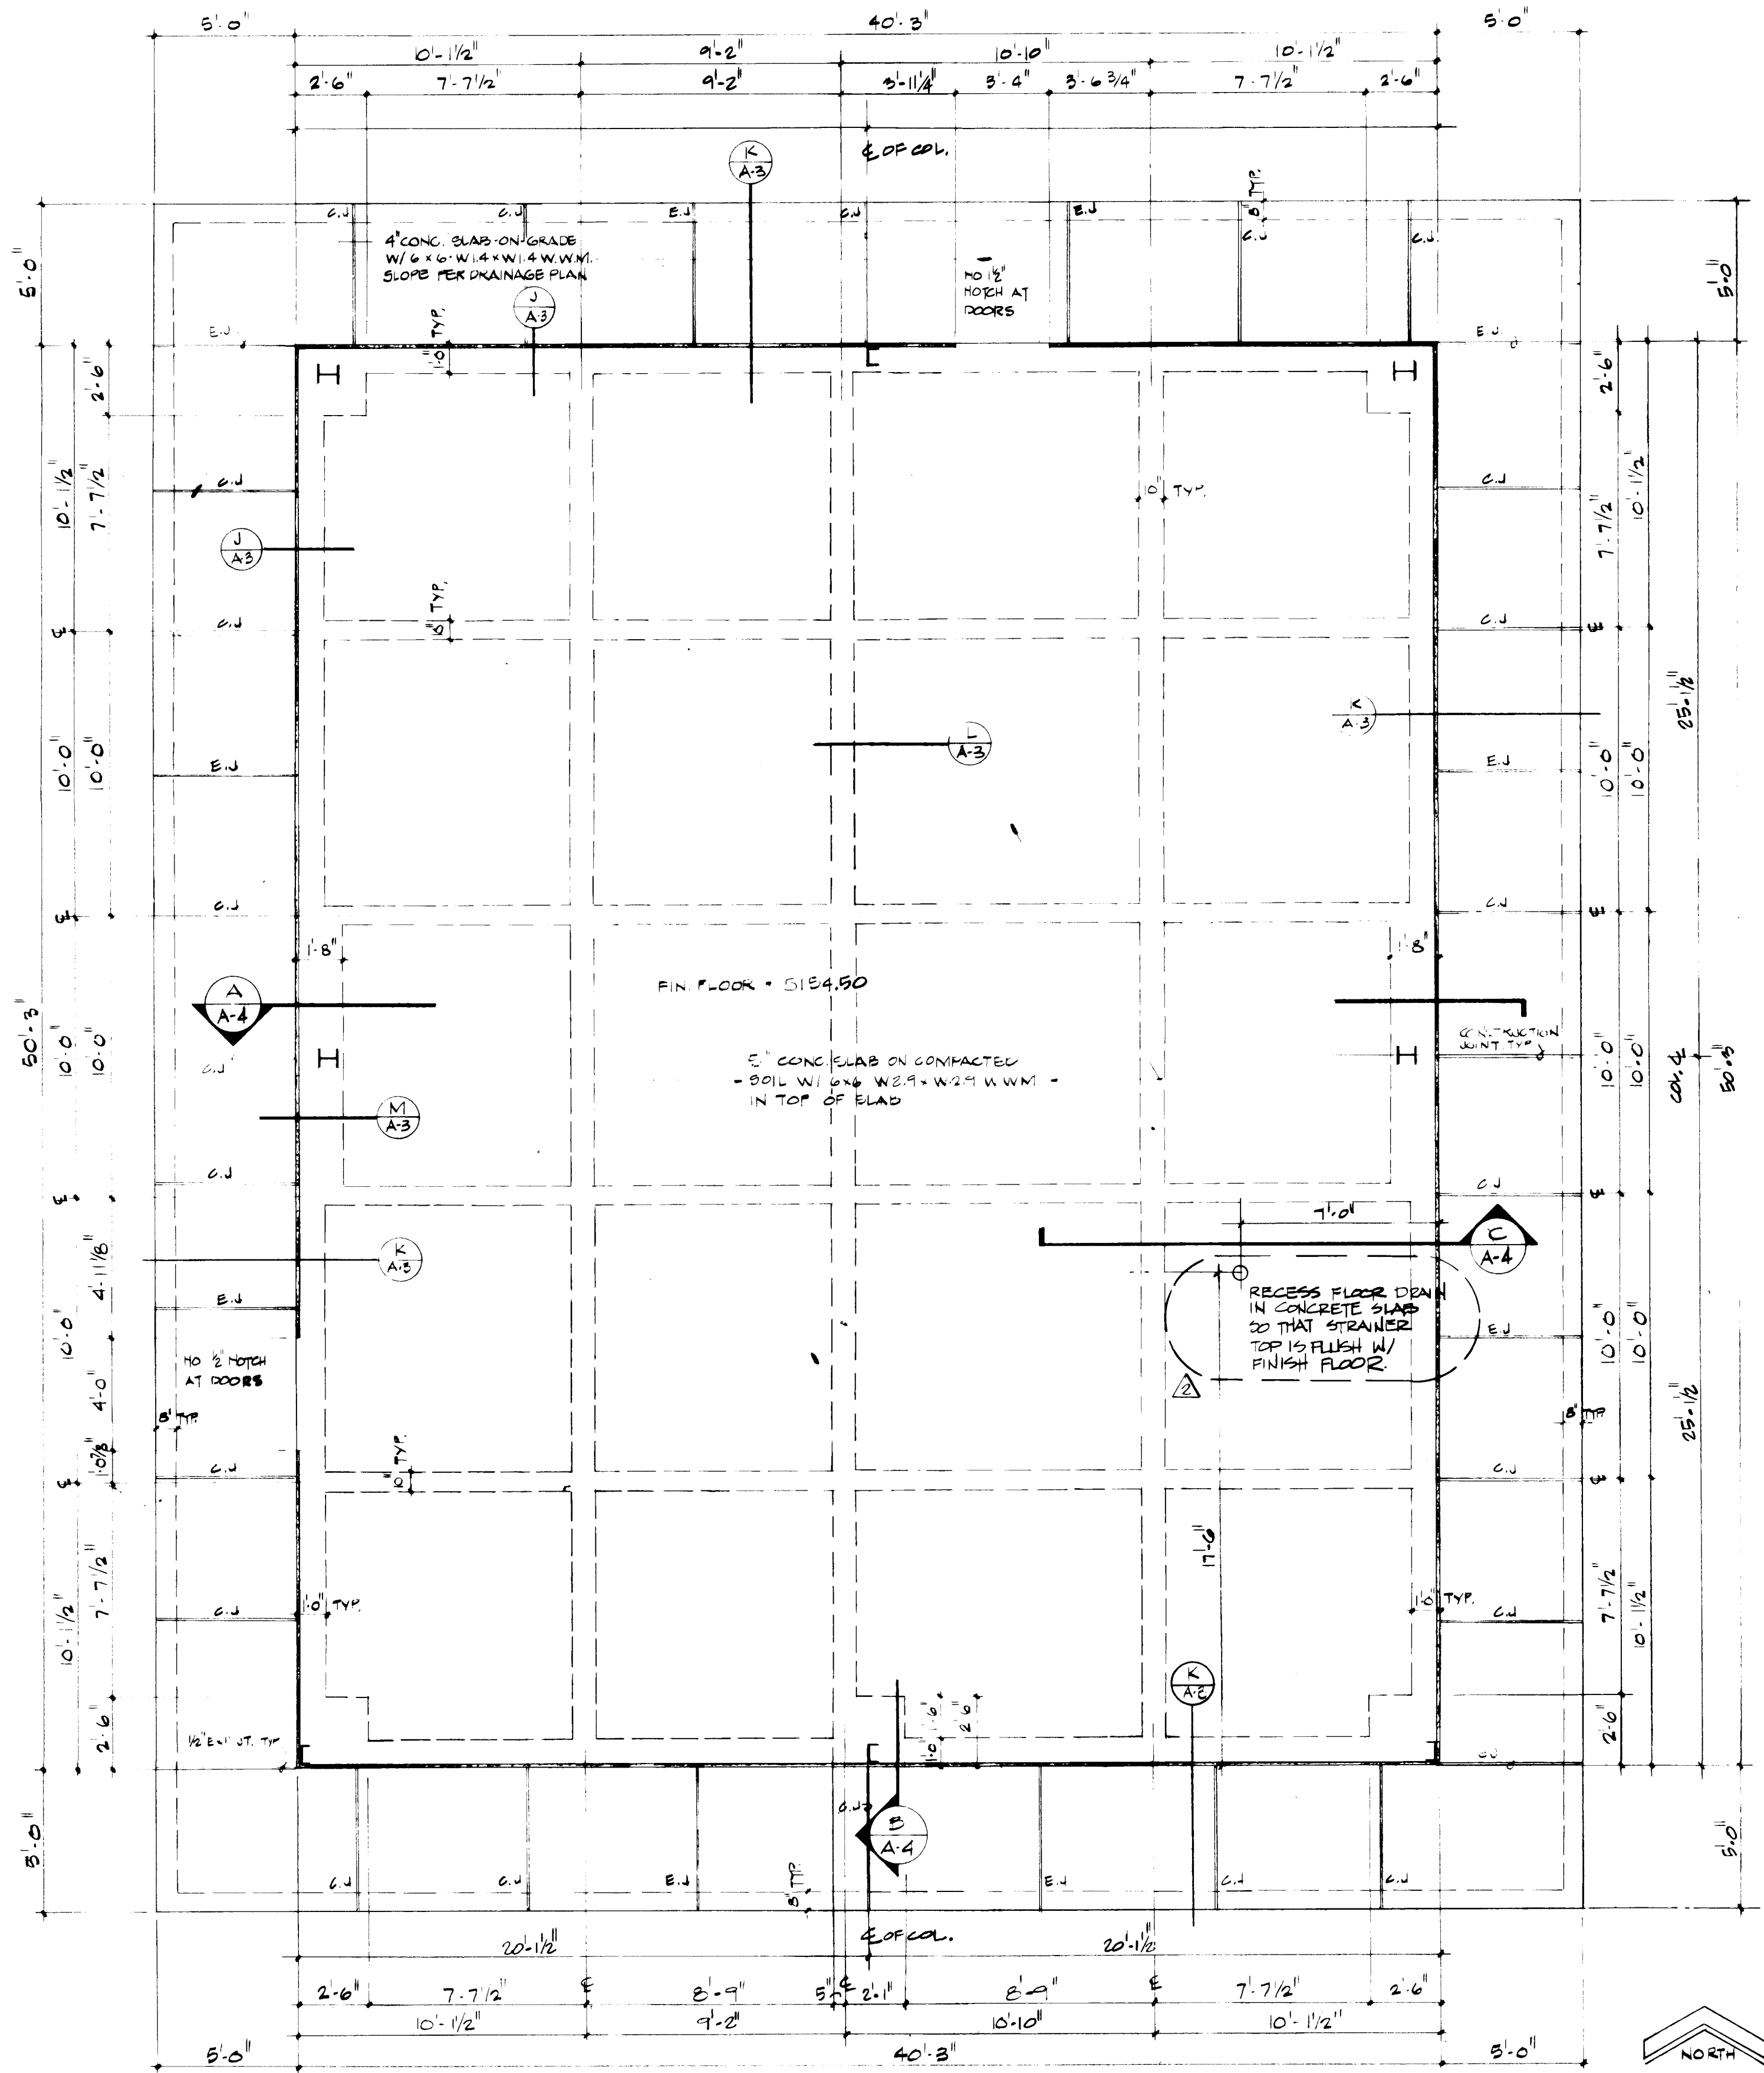

FOUNDATION PLAN - OFFICE/LABORATORY

 
1/4" = 1'-0"



- LEGEND**
- PRE-ENGINEERED METAL BLDG.
PER BLDG. V.F.C.R. W/ 16' 20 GA
METAL STUDS @ 16" O.C. INTERIOR
 - NON-LOAD BEARING PARTITION
20 GA. METAL STUDS @ 16" O.C.
 - LOAD BEARING PARTITION
16 GA. METAL STUDS @ 16" O.C.


FLOOR PLAN - OFFICE/LABORATORY

- LEGEND**
- PRE-ENGINEERED METAL BLDG.
PER BLDG. V.F.C.R. W/ 16' 20 GA
METAL STUDS @ 16" O.C. INTERIOR
 - NON-LOAD BEARING PARTITION
20 GA. METAL STUDS @ 16" O.C.
 - LOAD BEARING PARTITION
16 GA. METAL STUDS @ 16" O.C.

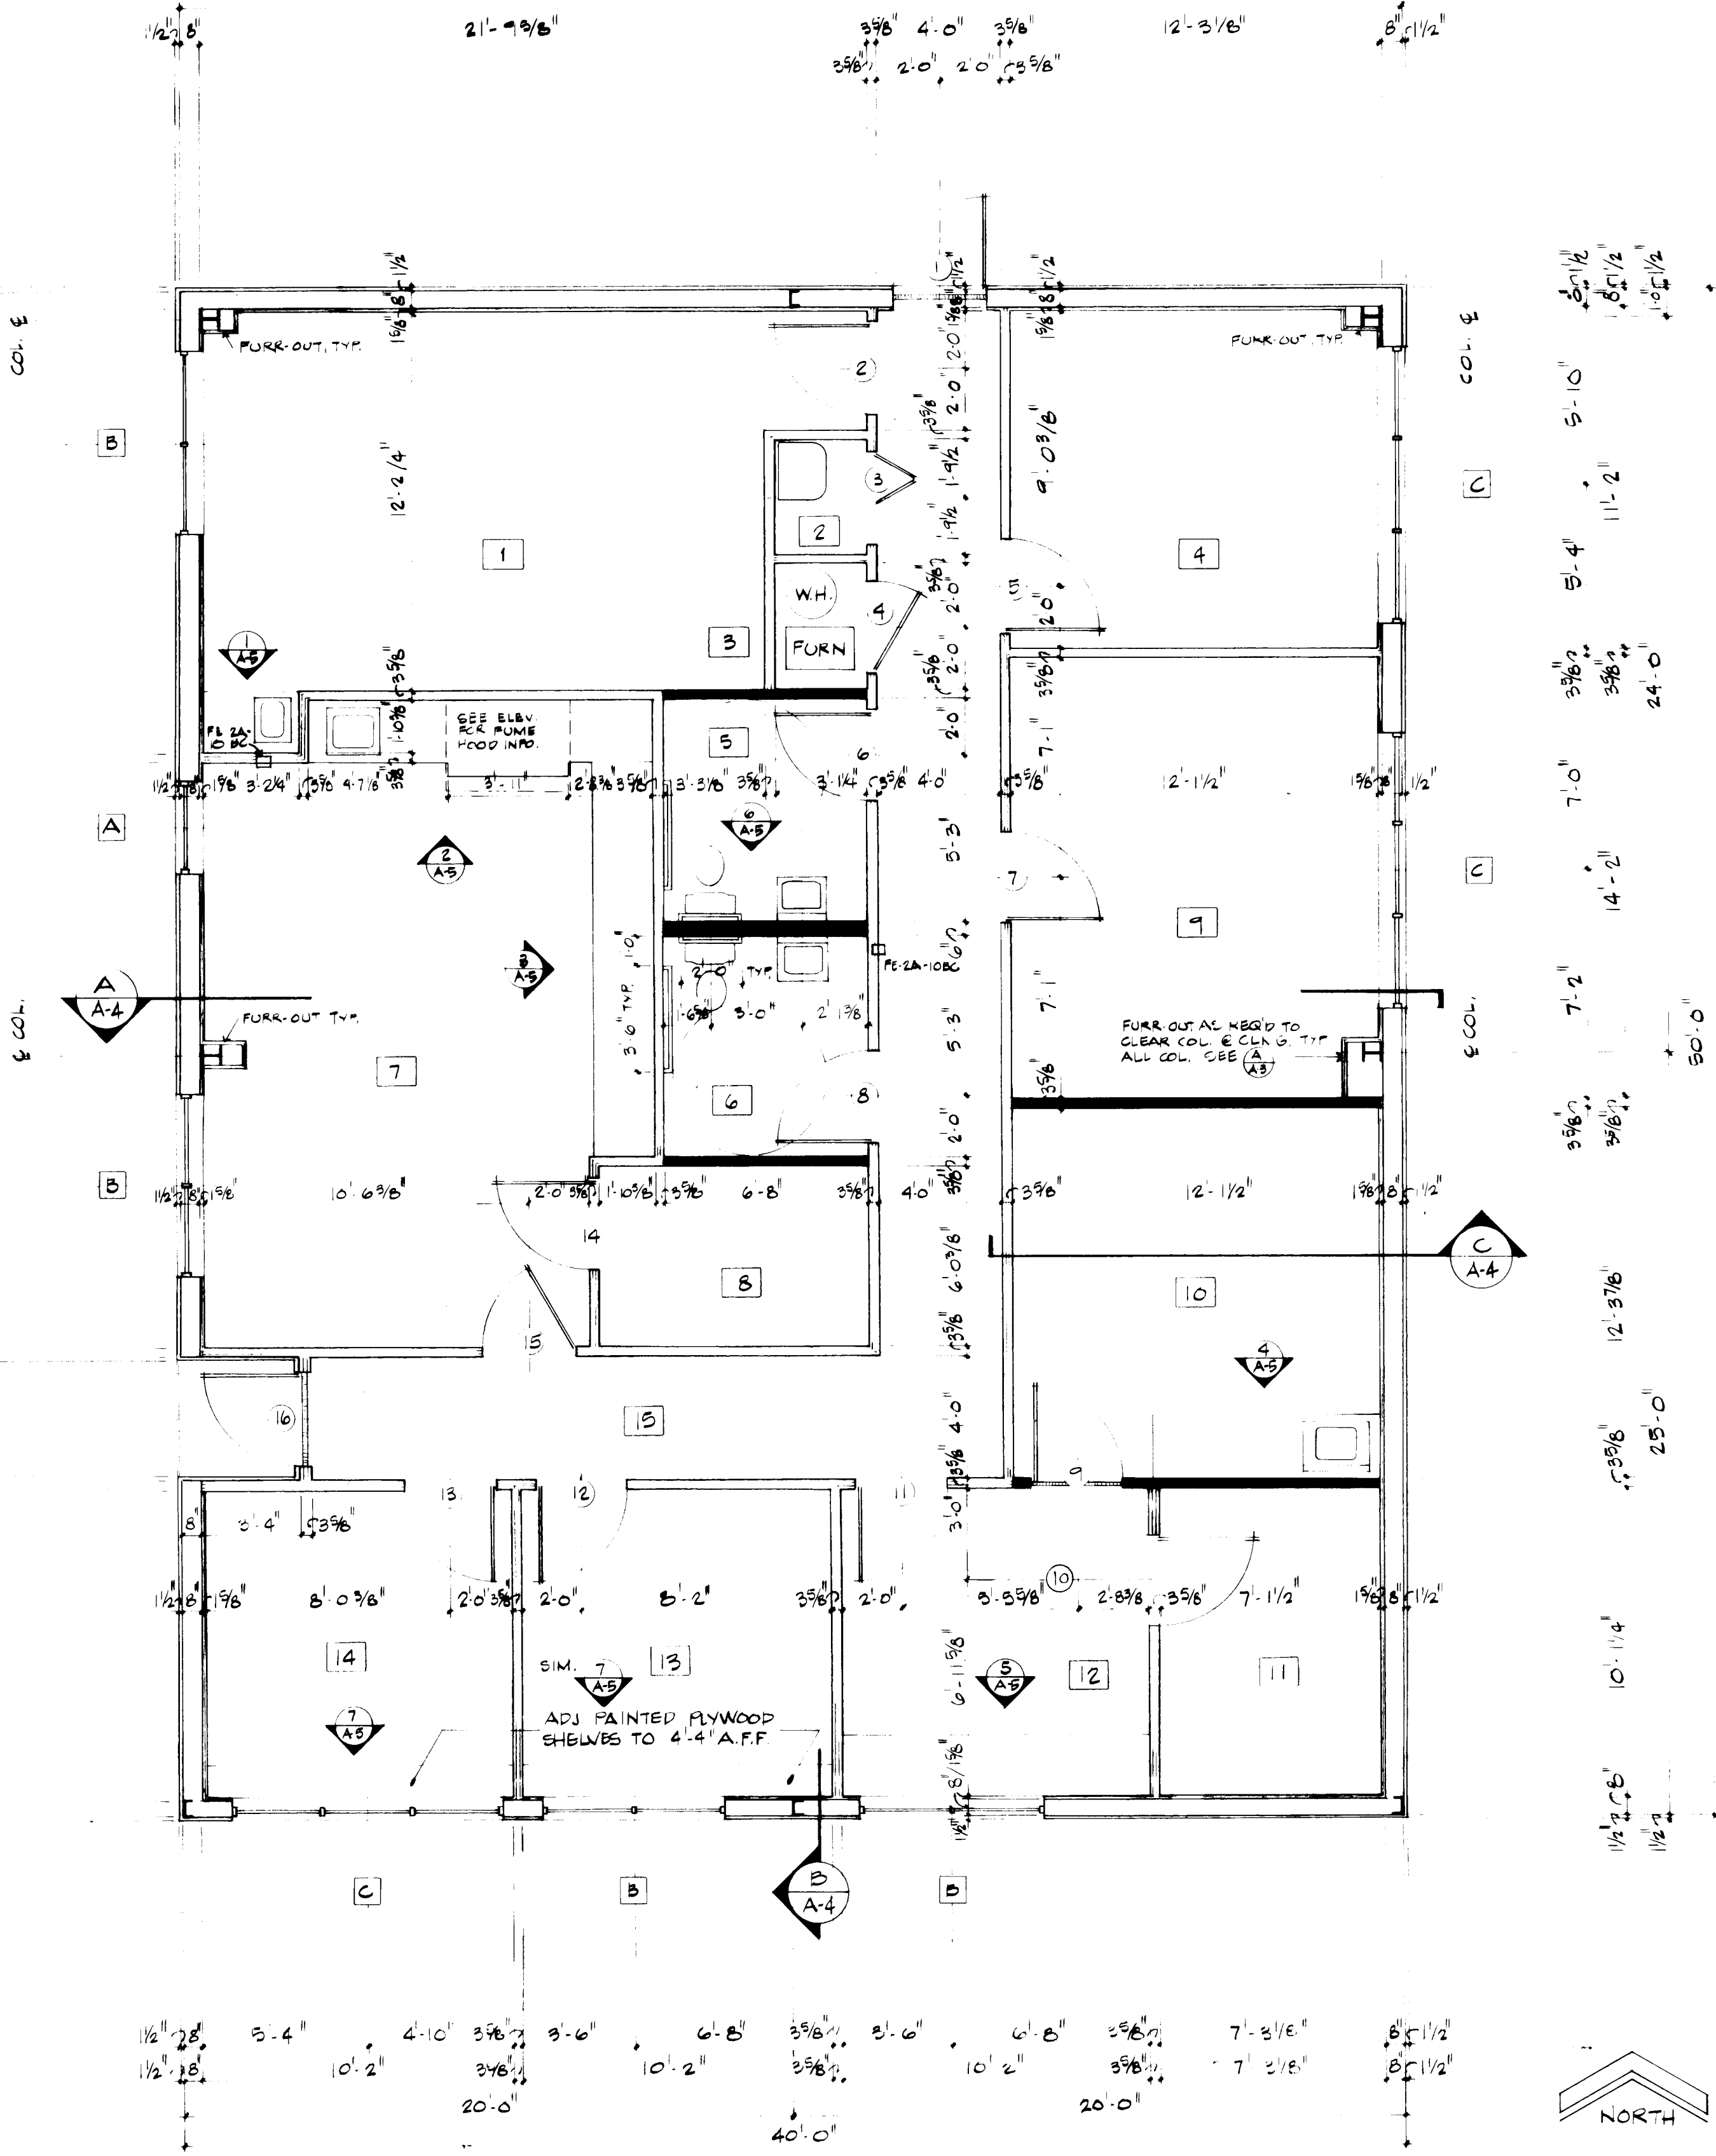

Russell B. Smith
1-12-88

26 28070588

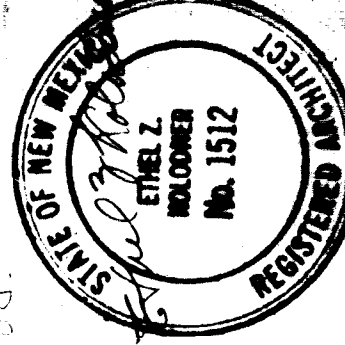


MONTESSA PARK RENOVATION
FOR THE
CITY OF ALBUQUERQUE
ENVIRONMENTAL HEALTH DEPARTMENT

RECORD DRAWING (See 28070588) prepared by Contractor, 2-11-88, 1-12-88.

DATE: 10-10-86
REV: 9-10-87
9-15-87


FOUNDATION PLAN REVISION
FLOOR PLAN
FOUNDATION PLAN

PROJECT NUMBER 2807 SHEET 4 OF 17

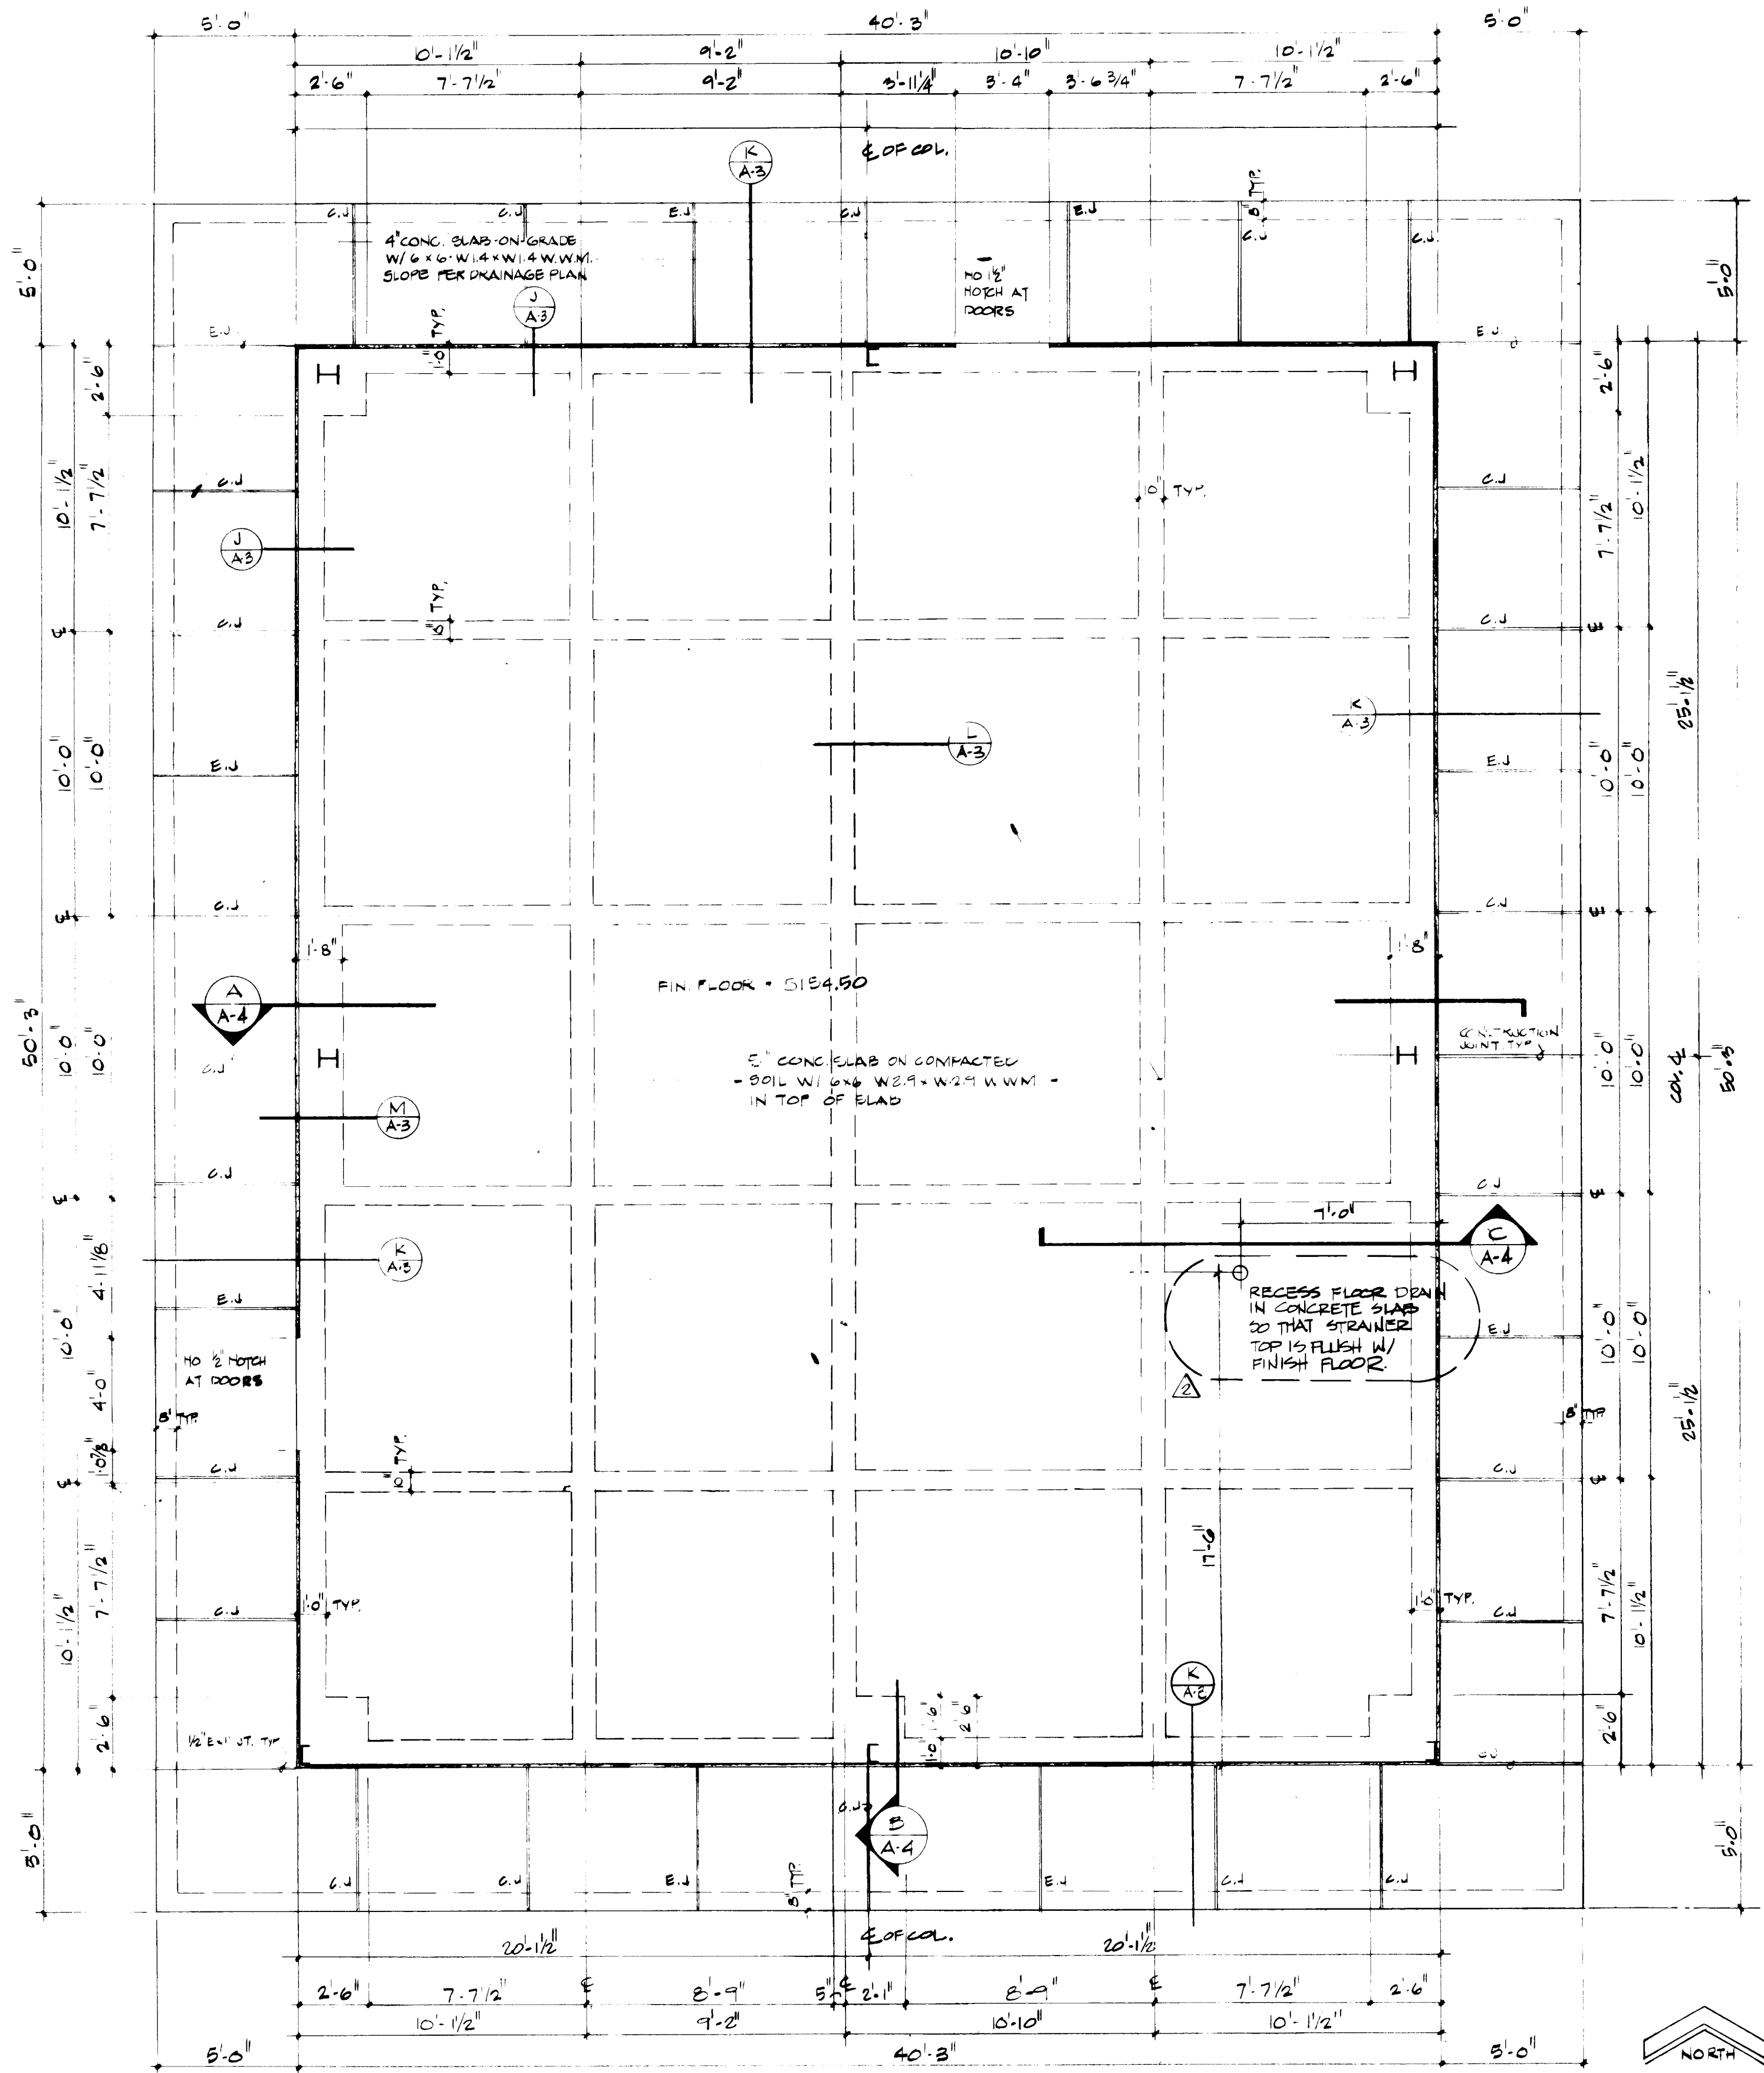

FOUNDATION PLAN - OFFICE/LABORATORY

1/4" = 1'-0"

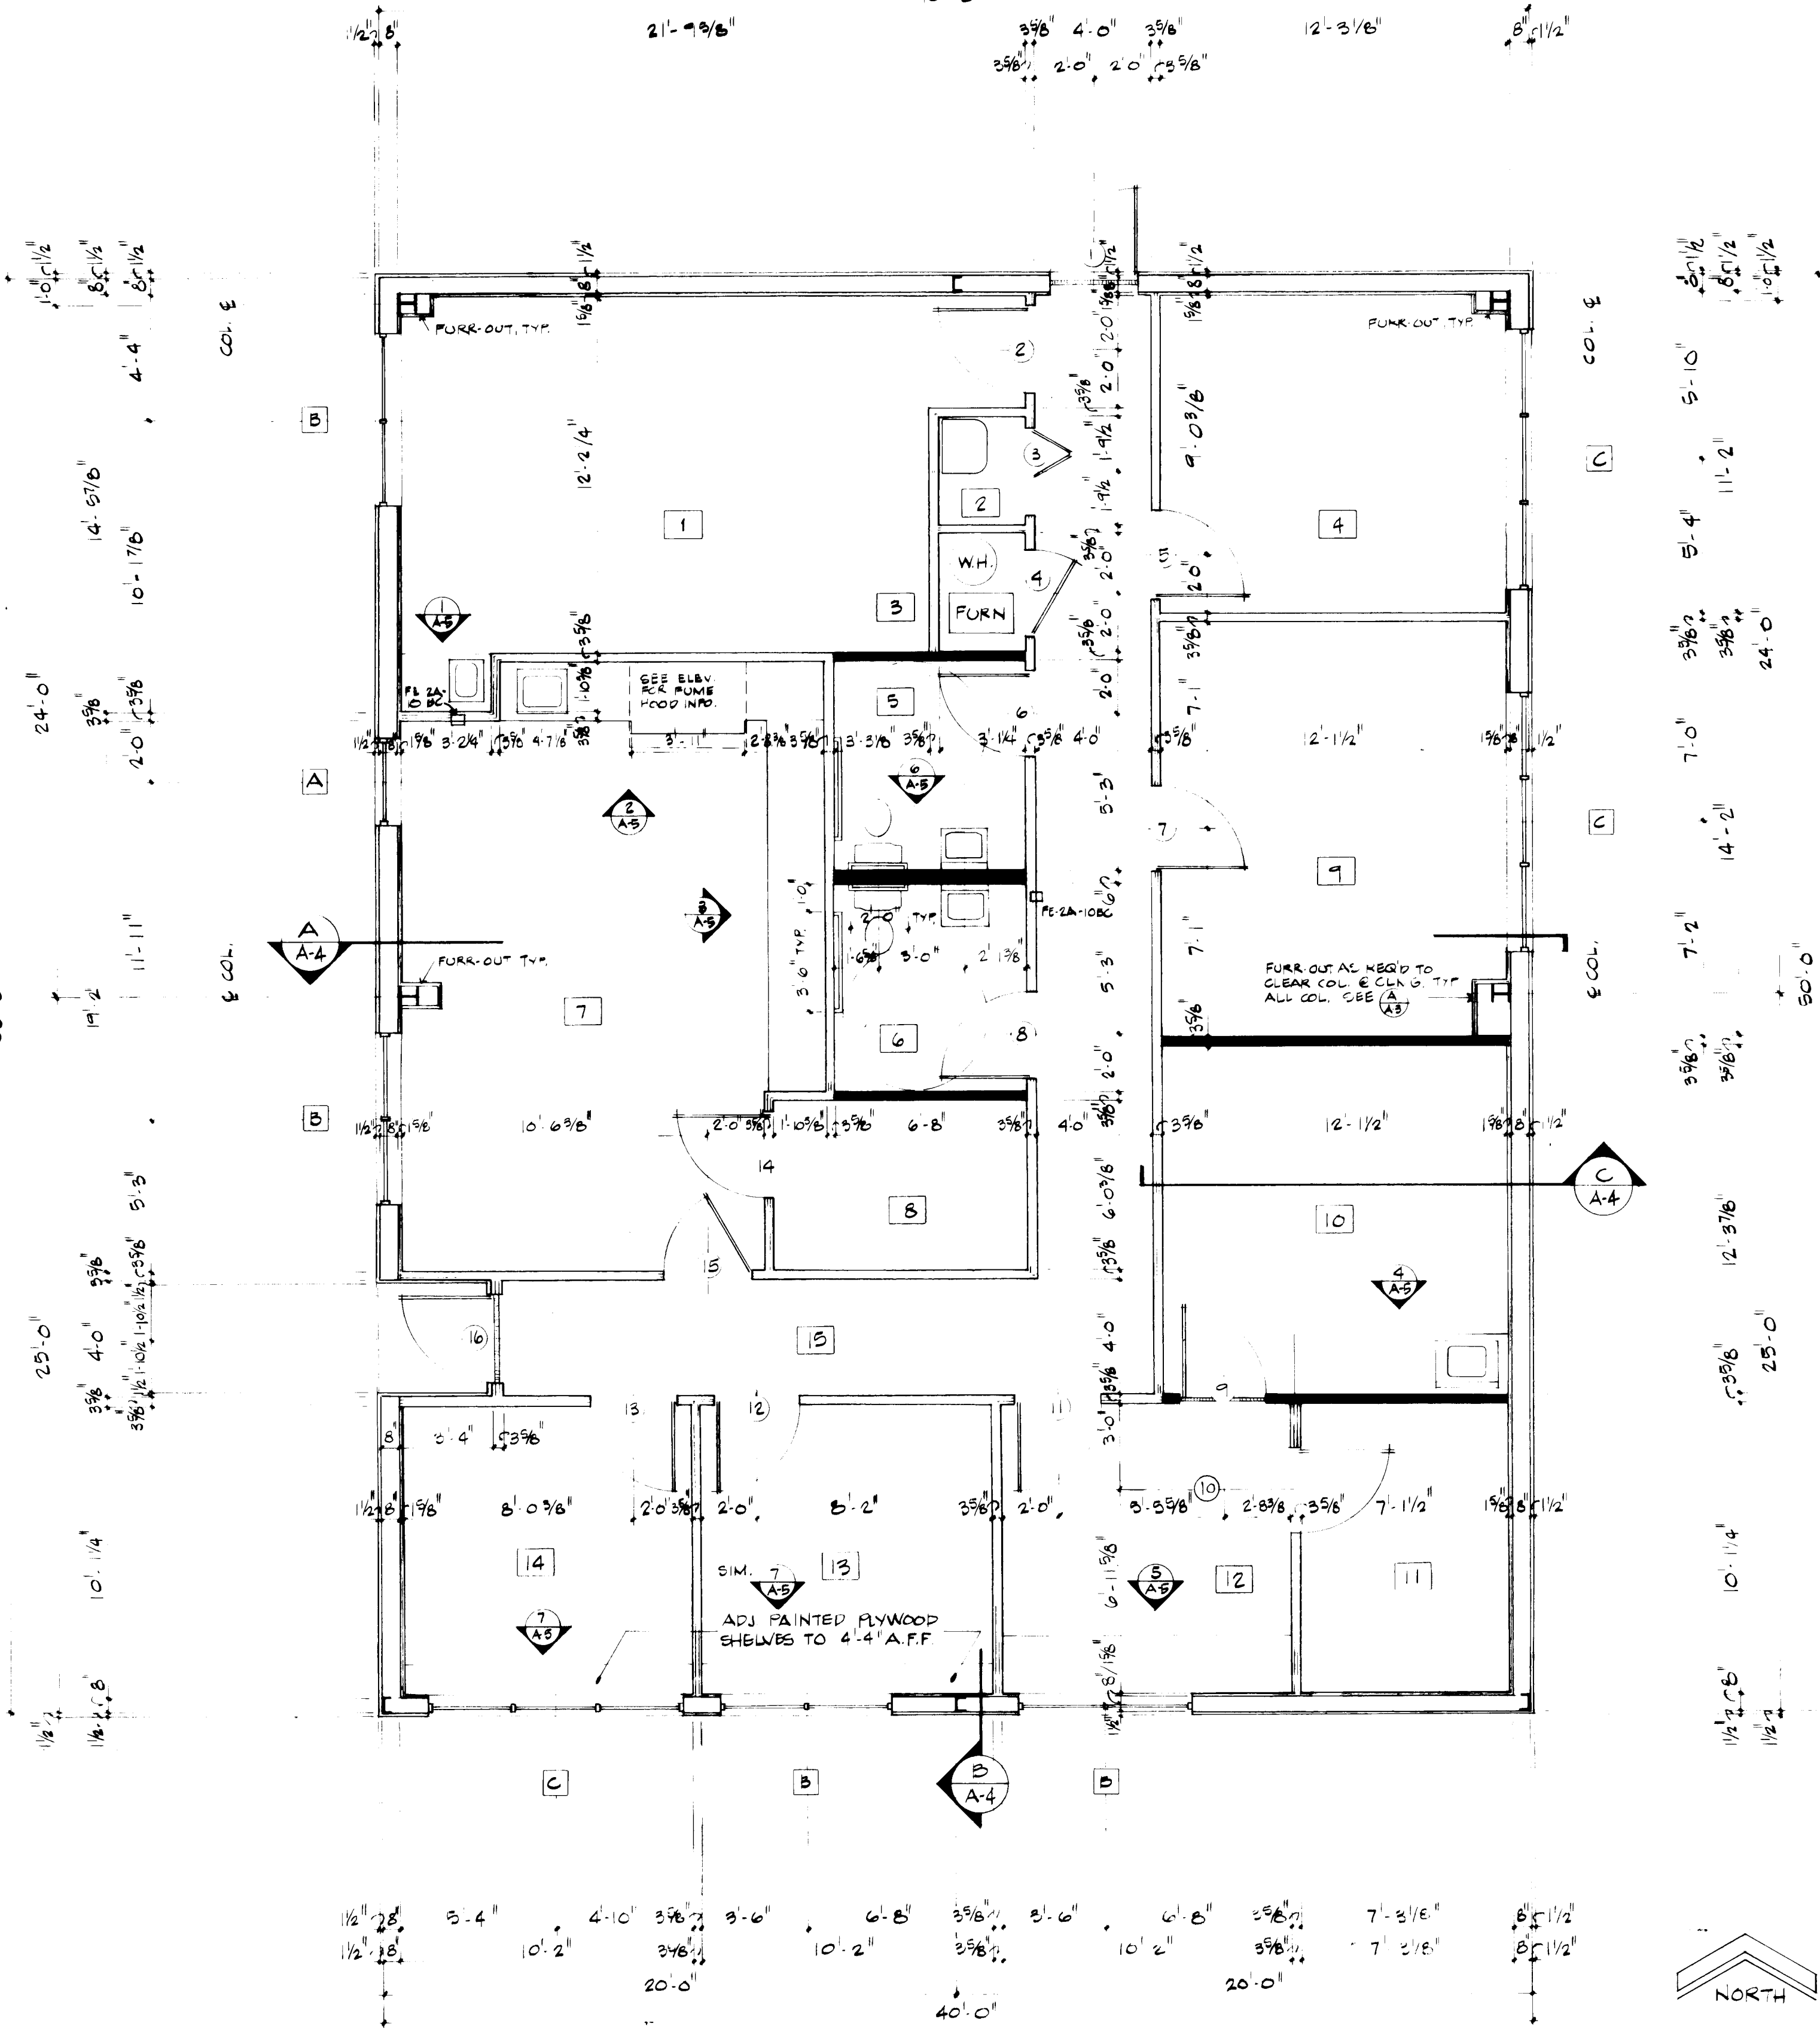


FLOOR PLAN - OFFICE/LABORATORY




LEGEND

- PRE-ENGINEERED METAL BLDG.
- PER BLDG. V.F.C.R. W/ 20 GA. METAL STUDS @ 10" O.C. INTERIOR
- NON-LOAD BEARING PARTITION 20 GA. METAL STUDS @ 10" O.C.
- LOAD BEARING PARTITION 16 GA. METAL STUDS @ 10" O.C.

Russell B. Smith
1-12-88

   26 28070588

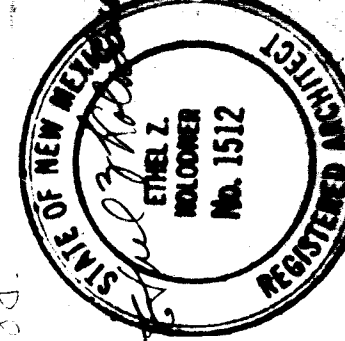



Additional information provided by Contractor, Federal Acquisition

OFFICE/LABORATORY BUILDING
FOUNDATION DETAILS K L N
ELEVATIONS

MONTESSA PARK RENOVATION
FOR THE
CITY OF ALBUQUERQUE
ENVIRONMENTAL HEALTH DEPARTMENT

METRON ARCHITECTS GROUP
413 Montclair Drive NE
Albuquerque, NM 87108
505 / 265-0800

A3

DATE: 10.15.86
REV: A 10.13.87


PROJECT NUMBER 2807

EST 5 of 17

STATE OF NEW MEXICO
ETHEL Z.
MOLODNER
No. 1512
REGISTERED ARCHITECT


SPECIFIC NOTES - MECHANICAL

1. FR , 10" X 2", 50 CFM.
2. FR , 14" X 2", 100 CFM.
3. FR , 10" X 4", 125 CFM.
4. FR , 12" X 4", 150 CFM.
5. CD , 6" DIA. NECK, 100 CFM, 12" X 12" FACE.
6. CD , 8" DIA. NECK, 300 CFM, 24" X 24" FACE.
7. CD , 8" DIA. NECK, 400 CFM, 24" X 24" FACE.
8. CD , 8" DIA. NECK, 425 CFM, 24" X 24" FACE.
9. CD , 10" DIA. NECK, 500 CFM, 24" X 24" FACE.
10. CD , 10" DIA. NECK, 450 CFM, 24" X 24" FACE.
11. CD , 14" DIA. NECK, 950 CFM, 24" X 24" FACE.
12. 12" X 12" RA IN CEILING.
13. CONCRETE PLENUM BELOW FURNACE, SAME SIZE AS FURNACE OUTLET. RETURN AIR PLENUM UP FROM TOP OF FURNACE INTO CEILING SPACE. SEE INSTALLATION DETAIL.
14. EVAPORATIVE COOLER ON ROOF. SEE INSTALLATION DETAIL.
15. 20" X 20" SUPPLY DUCT DOWN THRU ROOF INTO CEILING SPACE.
16. 4" DIA. EXHAUST DUCT UP THRU ROOF TO WEATHER CAP.
17. COORDINATE UNDERFLOOR DUCTWORK WITH WASTE PIPING.
18. THERMOSTATICALLY CONTROLLED AIR VOLUME DAMPER.
19. DUCT DOWN FROM FAN INLET TO 12" X 12" RA IN CEILING.
20. 16" X 4" COMBUSTION AIR DUCT FROM GOOSENECK ABOVE ROOF DOWN TO 12" AFF.
21. INTERLOCK EXHAUST FAN WITH FURNACE MOTOR.
22. MOUNT EXHAUST FAN ON ROOF AND CONNECT TO EXHAUST HOOD IN ROOM BELOW. EXHAUST FAN TO BE SUPPLIED WITH HOOD. VERIFY ALL CONNECTIONS AND MOUNTING REQUIREMENTS.
23. CONNECT WATER HEATER FLUE AND FURNACE FLUE TO SINGLE 5" DIA. FLUE AND EXTEND THRU ROOF TO WEATHER CAP.
24. MOUNT HUMIDIFIER AT 84" AFF.

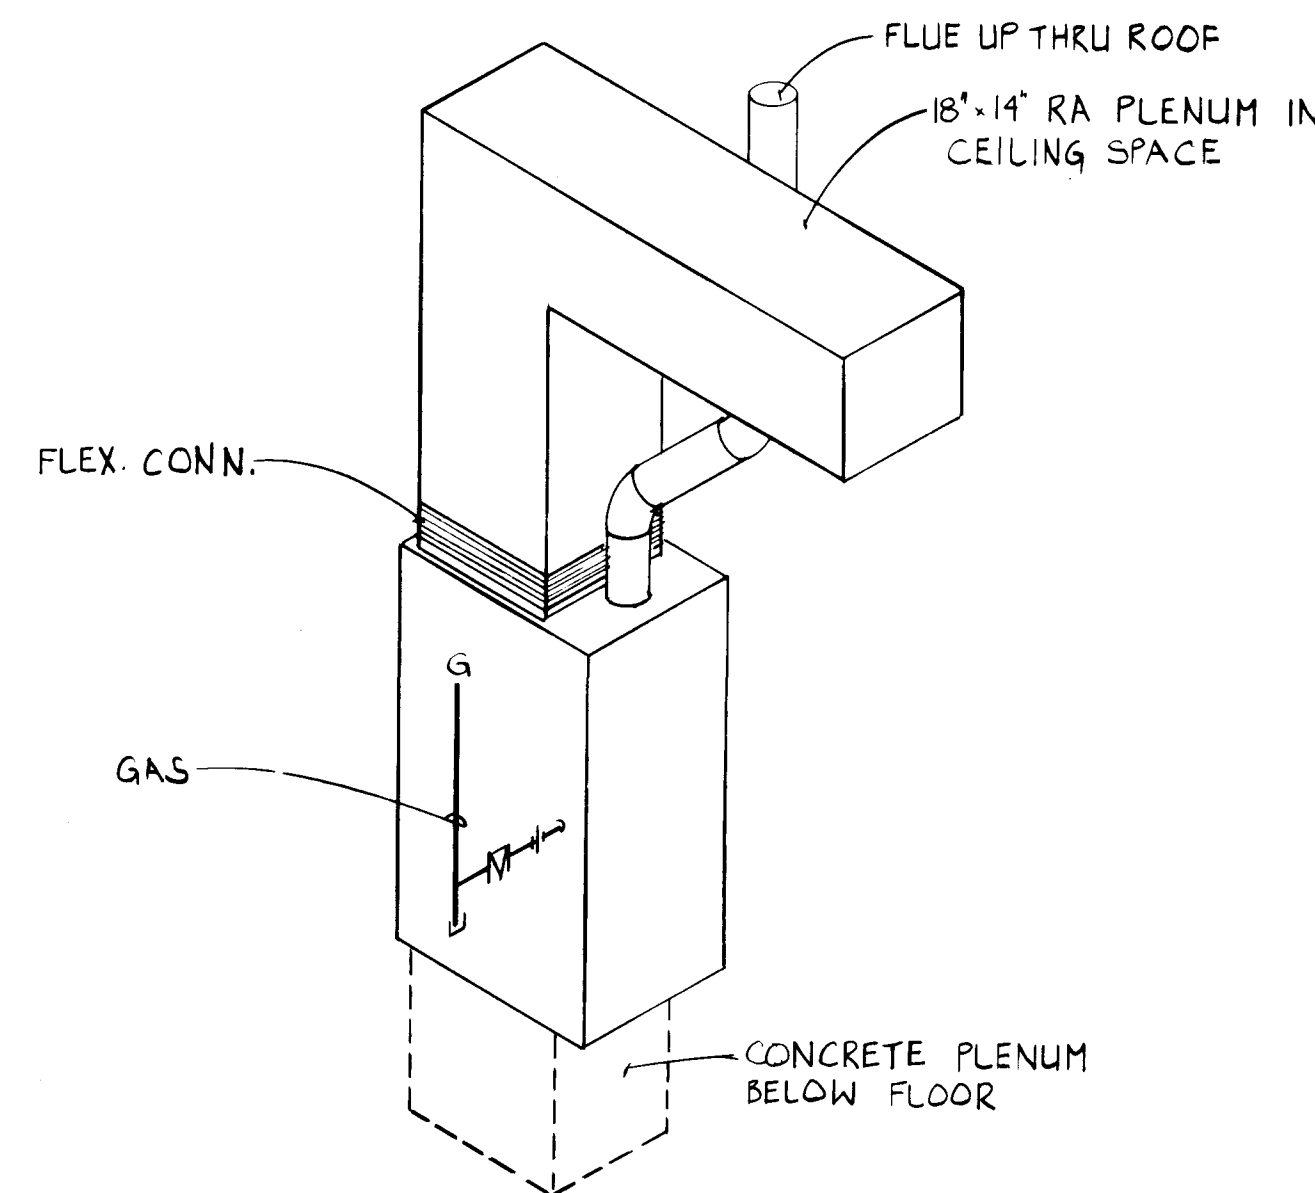

FURNACE INSTALLATION SCHEMATIC
NO SCALE


EQUIPMENT SCHEDULE						
1	FURNACE: AGA APPROVED, NATURAL GAS FIRED, DOWN FLOW FURNACE ORFICED FOR 5000' ELEVATION. UNIT SHALL HAVE MULTI-SPEED, DIRECT DRIVE FAN AND SPEED TAP SELECTOR, PRINTED CIRCUIT CONTROL CENTER, SOLID STATE BLOWER CONTROL, CROSS-PORT DESIGN BURNERS FABRICATED FROM ALUMINIZED STEEL, ELECTRIC SPARK PILOT, 115 V - 1 PH ELECTRICAL, LIMIT CONTROLS AND GAS TRAIN, TRANSFORMER, HEATING THERMOSTAT, AND 1" THICK THROUGHWAY FILTERS. MODEL NUMBERS ARE PAYNE.					
SYMBOL	MODEL	CFM	ESP	HP	BTUH INPUT	
1	3960048100	1350	.6"	1/2	100,000	
2	EVAPORATIVE COOLER: DRIP TYPE, SIDE DISCHARGE COOLER WITH PADS, PUMP, FLOAT AND MAKE-UP ASSEMBLY, AND 26 GAUGE GALVANIZED STEEL COVERS. MOTORS SHALL BE TWO SPEED AND THE CAPACITIES ARE CERTIFIED. MODEL NUMBERS ARE MCGRAW-EDISON.					
SYMBOL	MODEL	CFM	ESP	HP	VOLTS	PH
2	ES630	4000	.3"	3/4	115	1
3	EXHAUST FAN: ROOF MOUNTED, DIRECT DRIVEN, CENTRIFUGAL TYPE EXHAUST FAN. PROVIDE WITH BACKDRAFT DAMPER, BIRD SCREEN AND UNIT MOUNTED DISCONNECT SWITCH. MODEL NUMBERS ARE GREENHECK.					
SYMBOL	MODEL NO.	CFM	ESP	VOLTS	PH	HP
3	Q-65-D	230	.125	115	1	1/30
4	EXHAUST FAN: ROOF MOUNTED, DIRECT DRIVEN, CENTRIFUGAL TYPE EXHAUST FAN WITH NO SPARKING CONSTRUCTION AND EXPLOSION PROOF MOTOR. PROVIDE WITH BACKDRAFT DAMPER, BIRD SCREEN AND UNIT MOUNTED DISCONNECT SWITCH. MODEL NUMBERS ARE GREENHECK.					
SYMBOL	MODEL NO.	CFM	ESP	VOLTS	PH	HP
4	G-75-D	375	.125	115	1	1/25
5	HUMIDIFIER: SELF CONTAINED ELECTRODE STEAM HUMIDIFIER. UNIT SHALL HAVE A CAPACITY OF 10 LBS/HR OF STEAM. UNIT SHALL HAVE CONDUCTIVITY SENSOR, WATER LEVEL SENSOR, INTERNAL OVERLOAD PROTECTION, AUTOMATIC CYLINDER FLUSHING, LOCKING STEEL CABINET, AND ROOM DIFFUSION UNIT. THE UNIT SHALL BE PROVIDED WITH L.E.D. DISPLAYS TO INDICATE THE FOLLOWING: PERCENT OF SET POINT, FILL, DRAIN AND CYLINDER FULL, AND FAULT. ELECTRICAL - 220 V - 1 PH, 3.3 KW. HUMIDIFIER MODEL EST 220110.					
SYMBOL	MODEL NO.	CFM	ESP	VOLTS	PH	HP
5	SP-8	90	.125	120	1	1/125
6	EXHAUST FAN: CEILING MOUNTED, DIRECT DRIVE, CENTRIFUGAL TYPE EXHAUST FAN WITH 1/2" ACOUSTICAL LINER, BACKDRAFT DAMPER AND ALUMINUM INLET GRILLE. MODEL NUMBERS ARE GREENHECK.					
SYMBOL	MODEL NO.	CFM	ESP	VOLTS	PH	HP
6	SP-8	90	.125	120	1	1/125
7	ELECTRIC BASEBOARD HEATER: SEE ELECTRICAL PLANS					
8	EXHAUST FAN: SUPPLIED WITH LABORATORY HOOD.					
CD	CEILING DIFFUSER: KRUEGER 1400 SERIES WITH OBD, STEEL CONSTRUCTION AND OFF-WHITE FINISH.					
RA	RETURN AIR GRILLE: KRUEGER EGC-5, WITH OFF-WHITE FINISH.					
FR	FLOOR REGISTER: KRUEGER 700 SERIES WITH OBD AND FACTORY BAKED BROWN FINISH.					

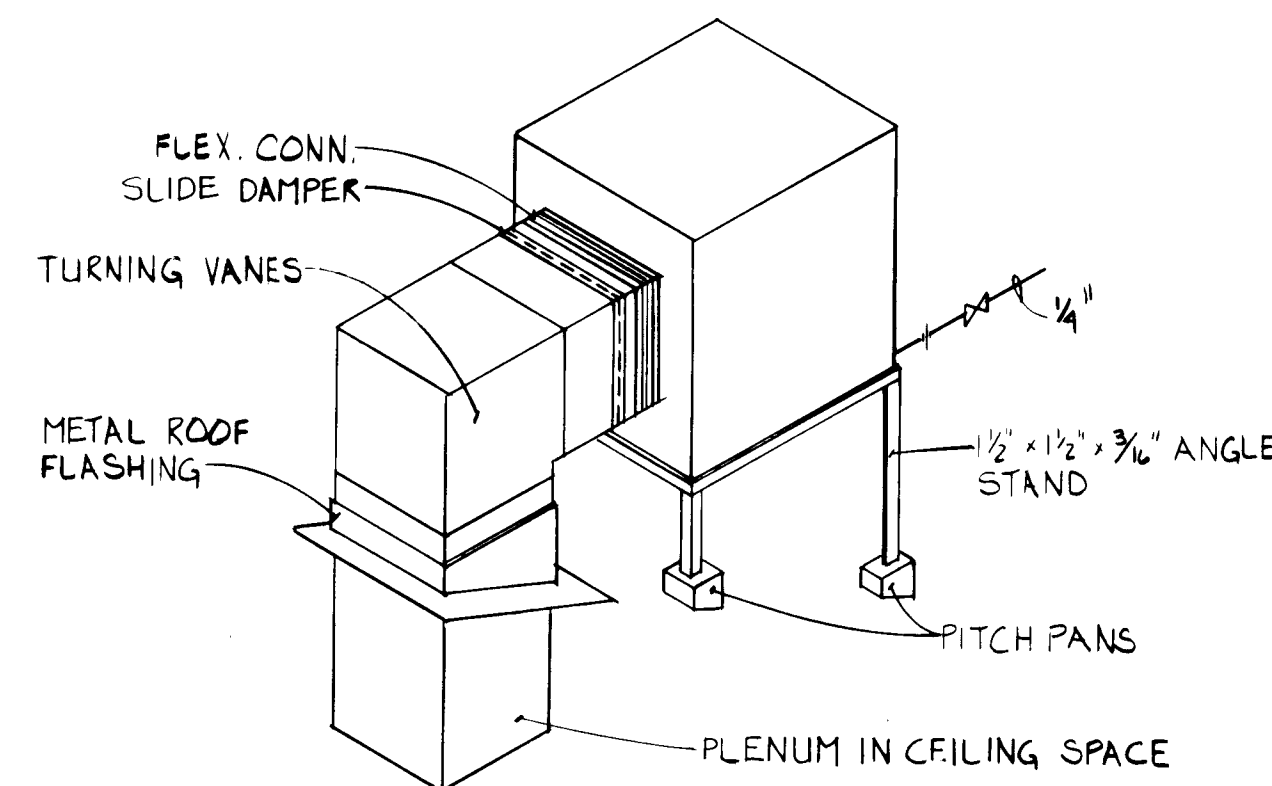

COOLER INSTALLATION SCHEMATIC
NO SCALE

LEGEND


- UNDERFLOOR DUCT
- ABOVE GROUND DUCT
- ROOFTOP EQUIPMENT

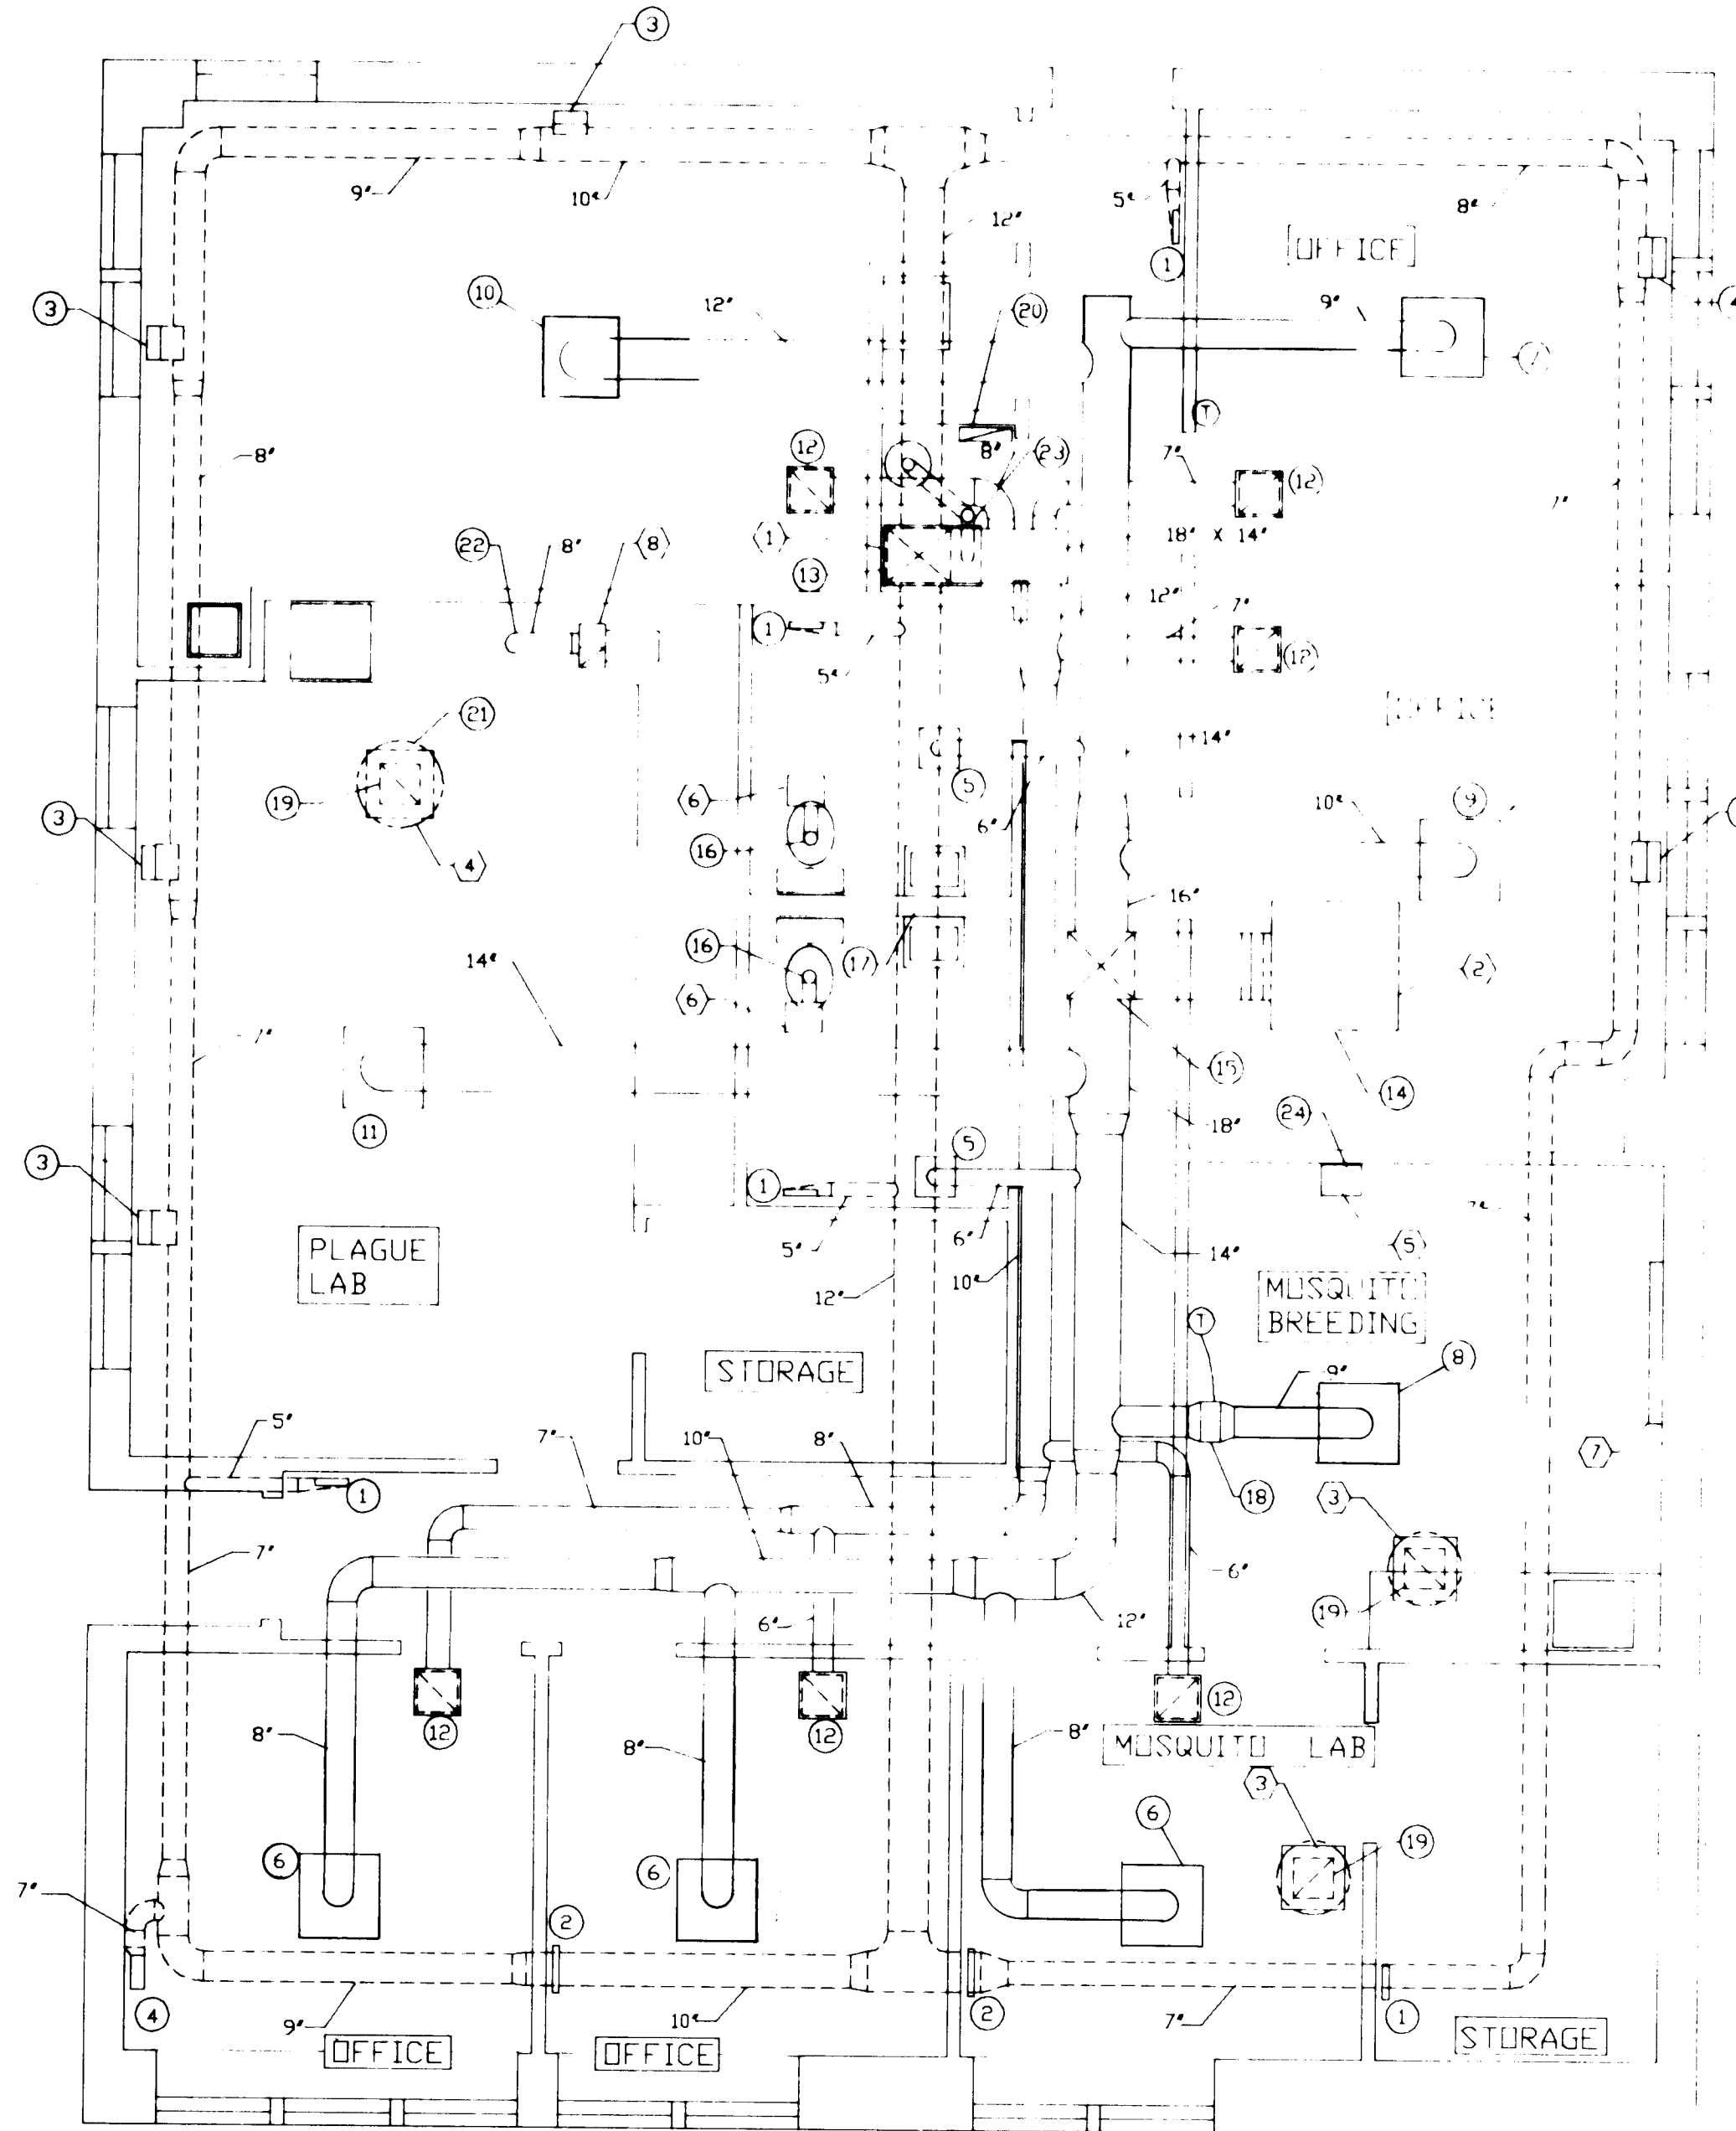

MECHANICAL PLAN
SCALE: 1/4" = 1'-0"




RECORD DRAWING - based on information provided by the client. 1/18/88

METRON ARCHITECTS GROUP 413 Montecito Drive NE Albuquerque, NM 87108 505 / 885-8880	MONTESSA PARK RENOVATION FOR THE CITY OF ALBUQUERQUE ENVIRONMENTAL HEALTH DEPARTMENT	OFFICE / LAB BUILDING MECHANICAL PLAN EQUIPMENT SCHEDULE MECHANICAL NOTES	DATE: 04/86 REV: 1	PROJECT NUMBER 2807 SHEET 13 OF 17
	APPROVED AS BUILT DRAWING 1-12-88			

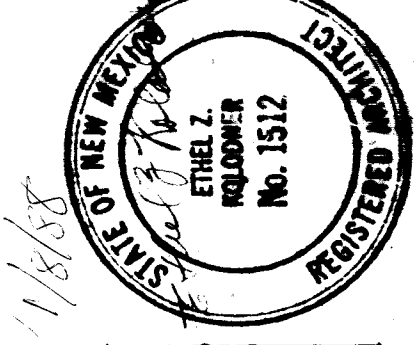

RECORD DRAWING Based on information provided by City of Albuquerque, Environmental Health Department, 1/18/88

DATE: 01-18-88 REV: 1		PROJECT NUMBER: 2807	SHEET: 6 OF 17
OFFICE / LAB BUILDING SECTION A SECTION B SECTION C		MONTESA PARK RENOVATION FOR THE CITY OF ALBUQUERQUE ENVIRONMENTAL HEALTH DEPARTMENT	
METRON ARCHITECTS GROUP 413 Montecito Drive NE Albuquerque, NM 87106 505/263-8880		A4	

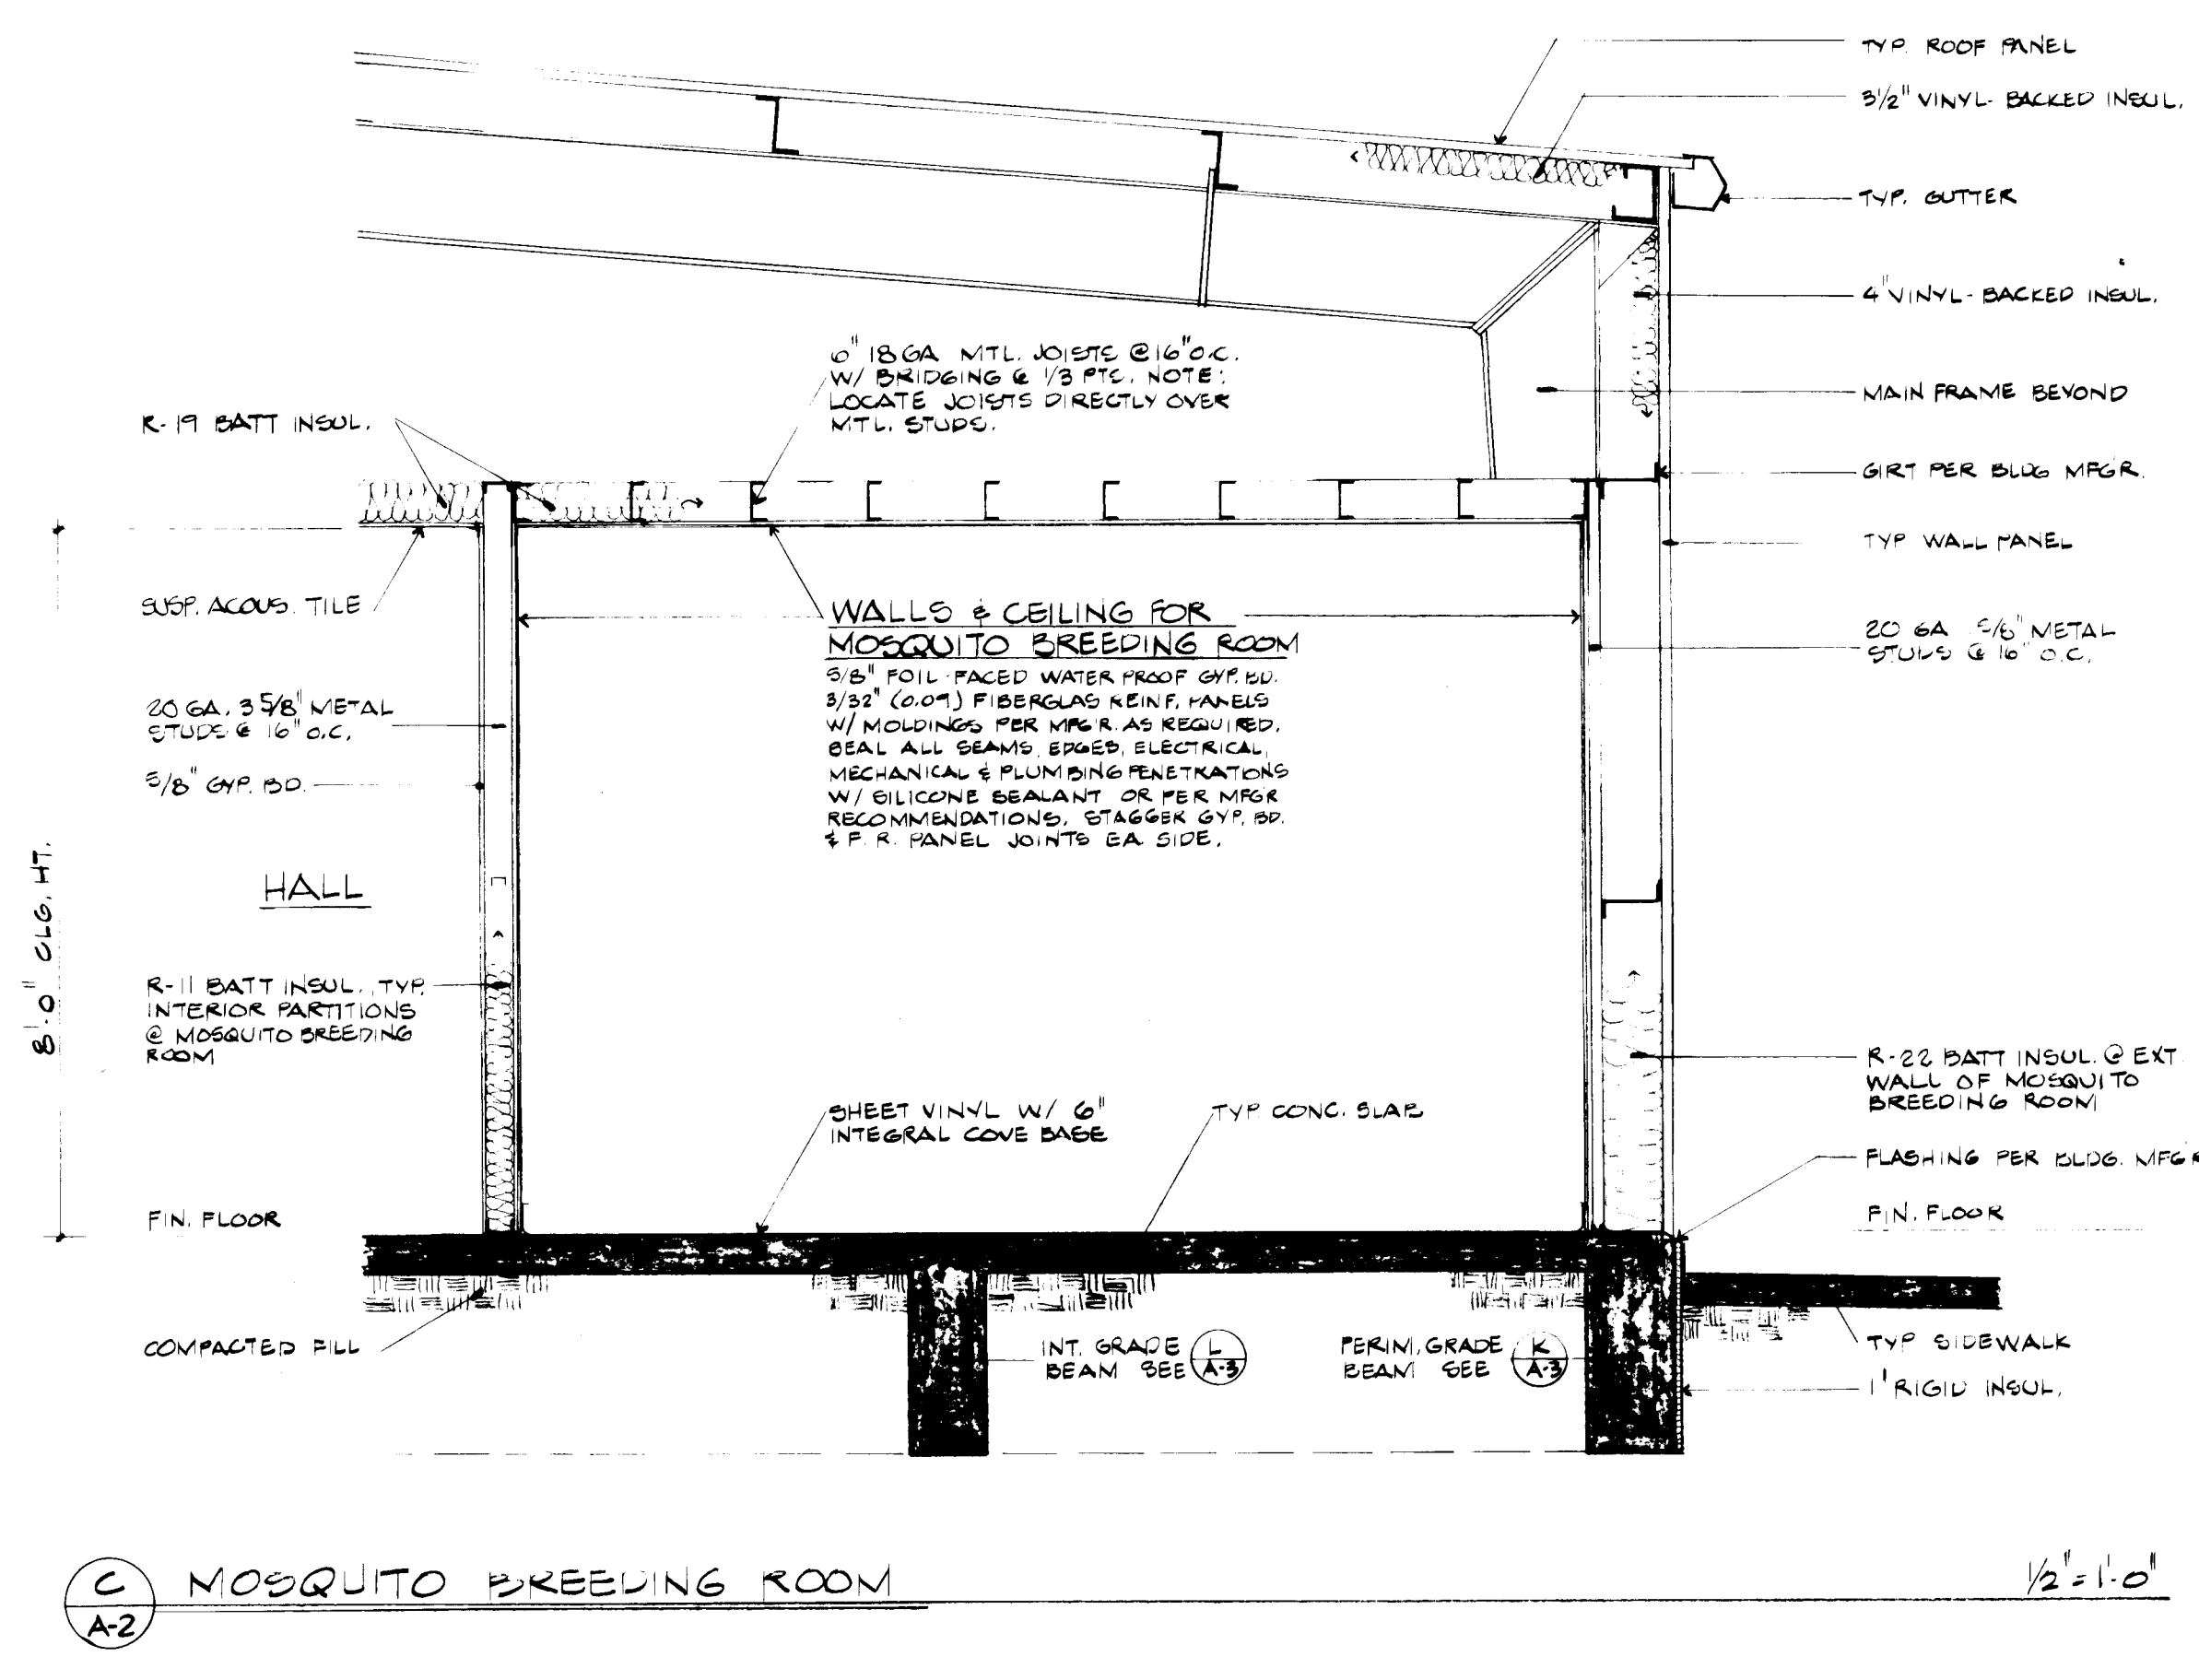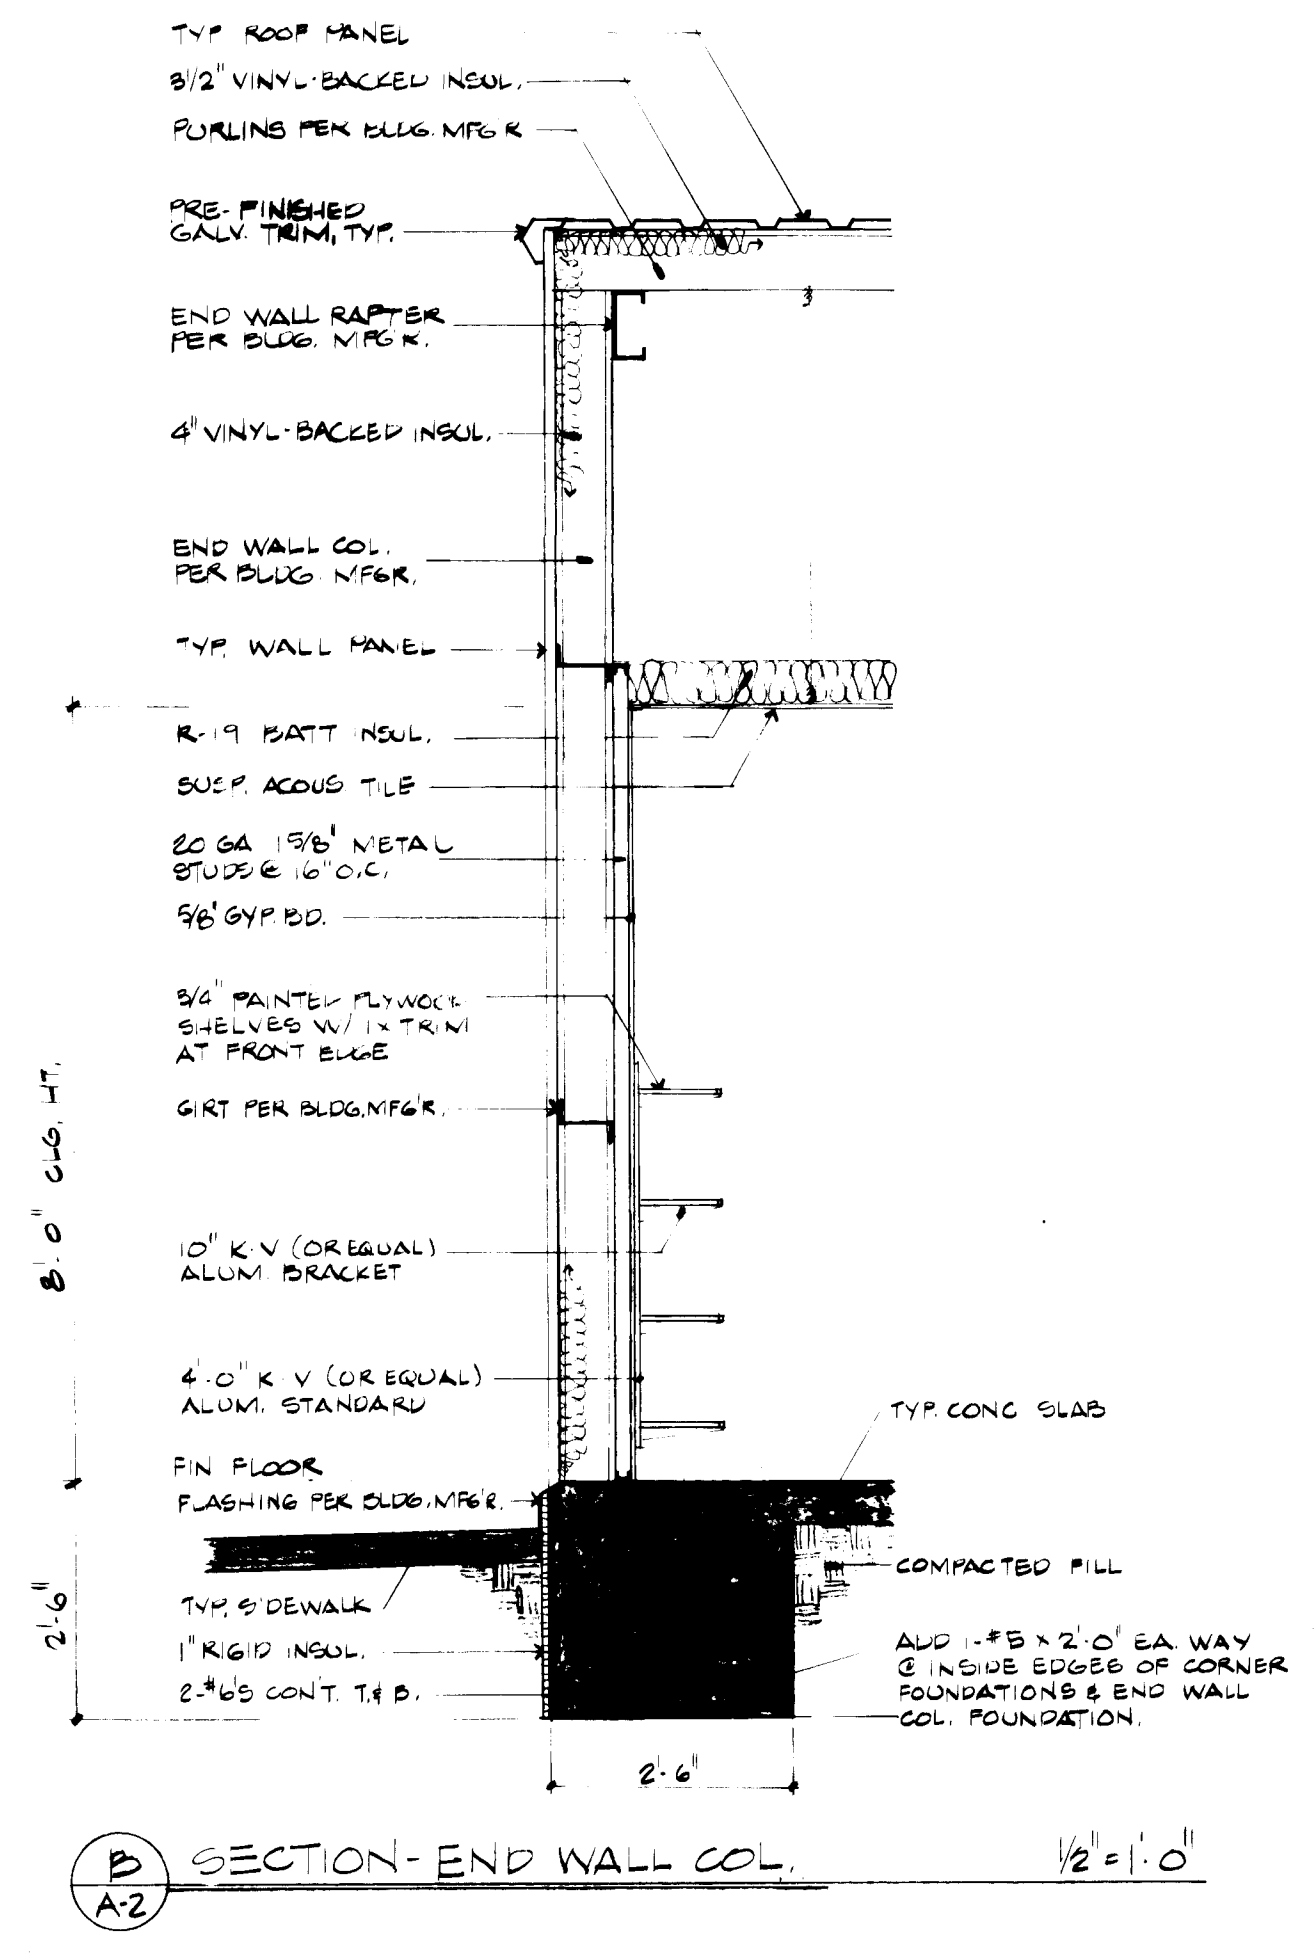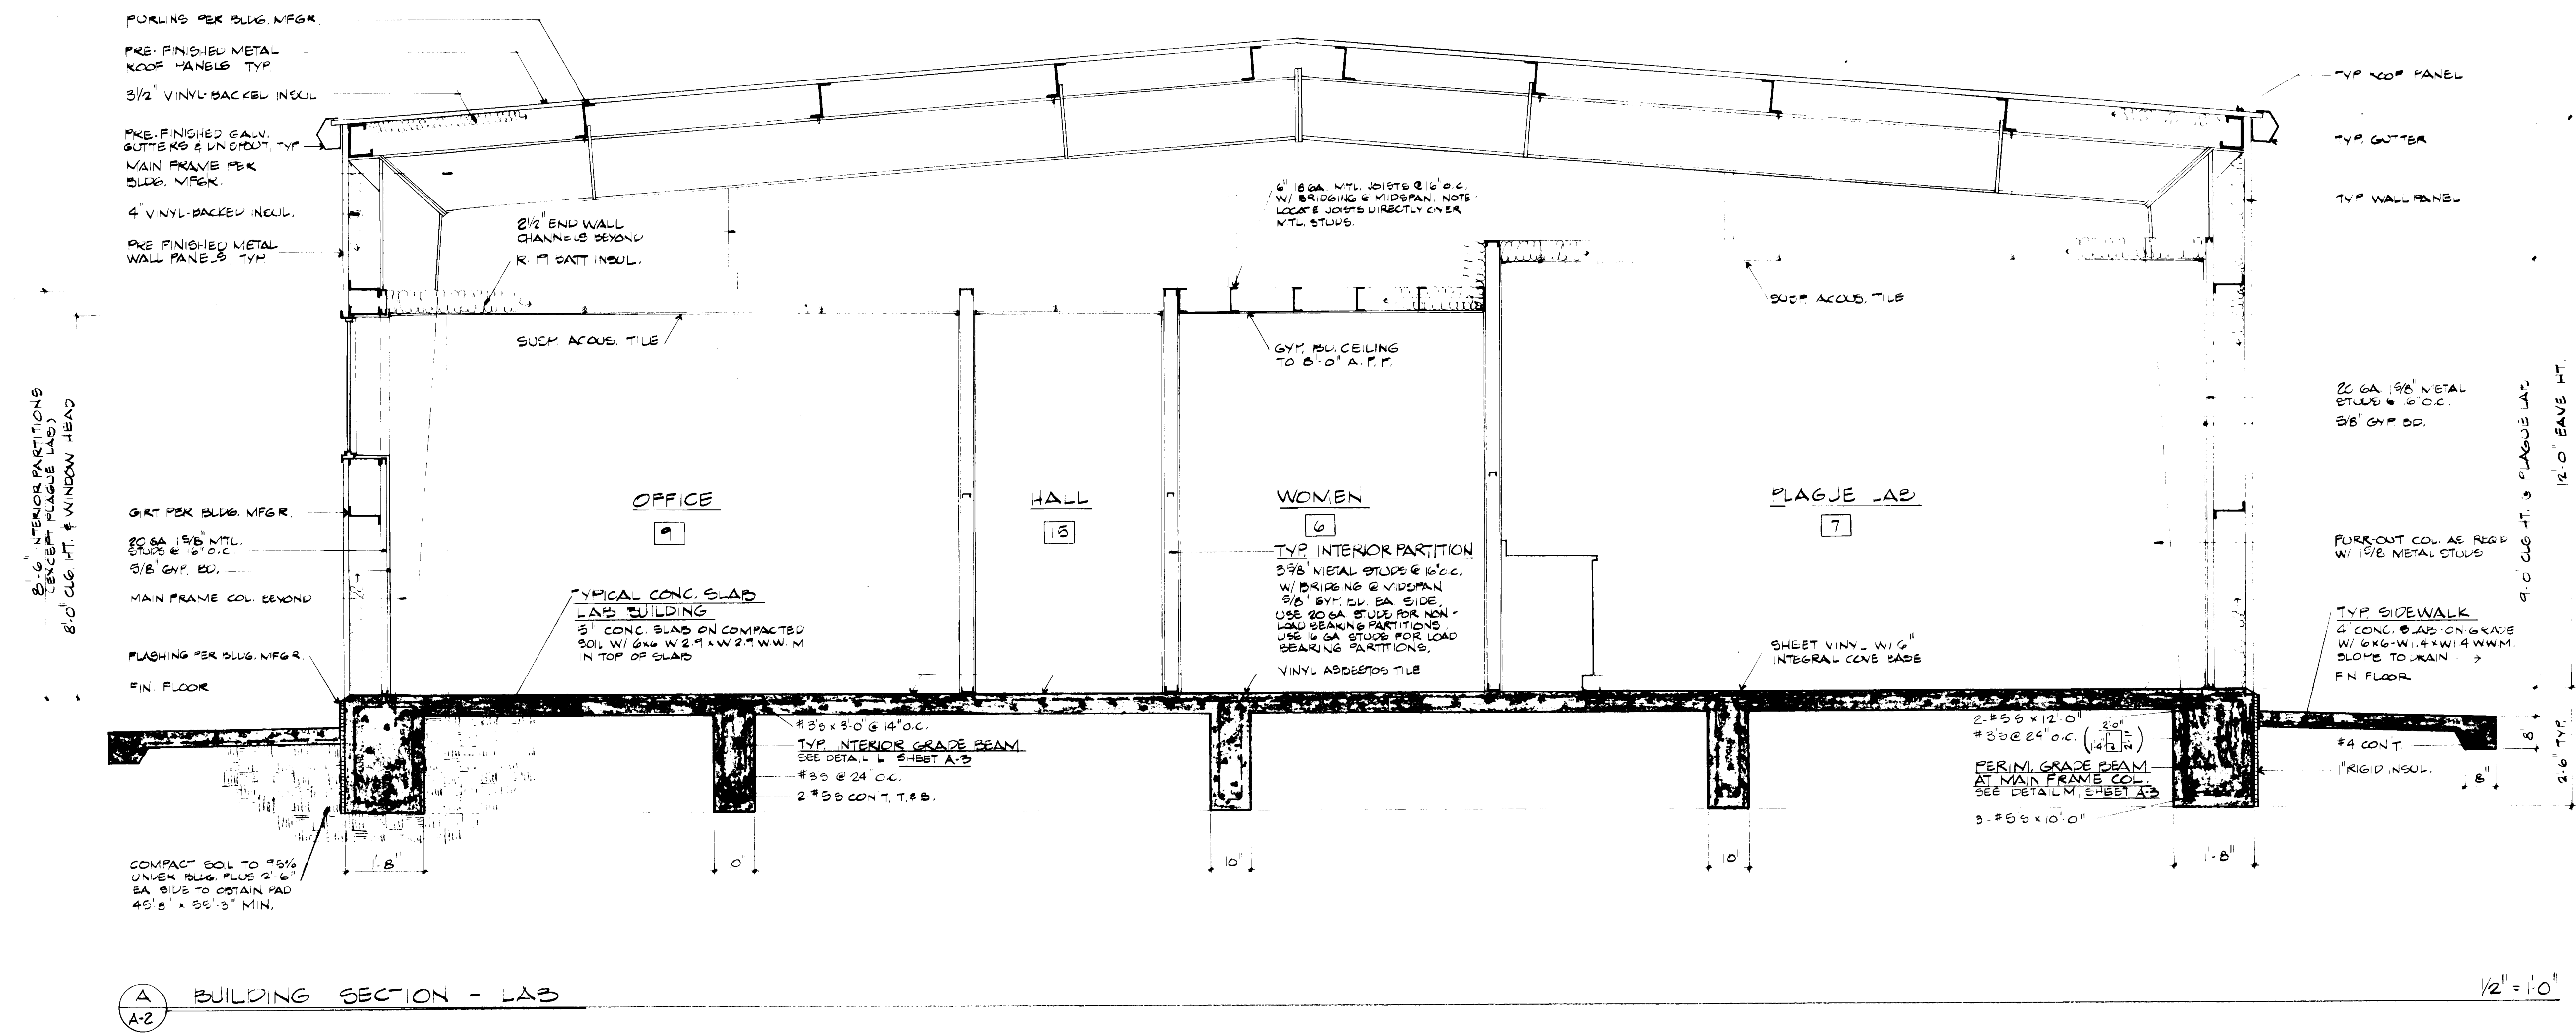

26 28070788

Russell B. Smith
1-12-88

GENERAL NOTES

MECHANICAL CONTRACTOR SHALL BE RESPONSIBLE FOR ALL ROUGH-IN AND CONNECTION OF EQUIPMENT REQUIRING COLD WATER, HOT WATER, INDIRECT WASTE, DIRECT WASTE AND VENT, DRAIN PIPING AND GAS PIPING.

MECHANICAL CONTRACTOR SHALL FURNISH AND INSTALL ALL TRAPS, TAILPIECES, AND SUPPLIES FOR FINAL CONNECTION TO ALL EQUIPMENT.

COORDINATE ALL PIPING BELOW SLAB WITH STRUCTURAL DRAWINGS AND UNDERGROUND DUCTWORK.

ALL PIPING SHALL BE CONCEALED EXCEPT WHERE NOTED AND IN MECHANICAL ROOMS.

CARE SHALL BE TAKEN TO AVOID MECHANICAL DUCTWORK, ELECTRICAL EQUIPMENT AND A/P-HANDLING EQUIPMENT. THIS CONTRACTOR SHALL BE RESPONSIBLE FOR COORDINATING ROUTING OF PIPING WITH CEILING CONTRACTOR AND SHEETMETAL CONTRACTOR. RELOCATION OF PIPING REQUIRED DUE TO POOR CO-ORDINATION BY THIS CONTRACTOR SHALL BE AT THEIR OWN EXPENSE.

ALL TRENCHING AND BACKFILL FOR PIPING SHALL BE THE RESPONSIBILITY OF THIS CONTRACTOR.

ALL PLUMBING AND MECHANICAL SYSTEMS SHALL COMPLY WITH ALL APPLICABLE CODES, ORDINANCES, AND OSHA STANDARDS.

ALL WATER PIPING BELOW FLOOR SHALL BE TYPE "L" COPPER, NO JOINTS, WRAPPED COMPLETE WITH X-TRU-COAT OR WITH 2" WIDTH OF #101 SCOTCHWRAP TAPE.


CONNECT GAS LINES TO EACH PIECE OF GAS FIRED EQUIPMENT WITH GAS COCK, UNION, DIRT LEG, AND FLEXIBLE CONNECTION.

CAULK ALL OPENINGS INTO MOSQUITO BREEDING ROOM AIR TIGHT.

SPECIFIC NOTES - WASTE PIPING

1. SEE SITE PLAN FOR CONTINUATION.
2. 1 1/2" VENT FROM FLOOR DRAIN UP IN WALL TO ABOVE CEILING.
3. 2" VTR.
4. 3" VTR.
5. ROUTE 4" WASTE LINE FROM SAND TRAP TO DISPOSAL POND. SEE SITE PLAN FOR CONTINUATION.
6. 3/4" CW TO EXISTING EQUIPMENT BUILDING. SEE SITE PLAN FOR CONTINUATION.
7. 2" VENT LINE UP FROM BELOW GRADE AND UP ALONG WALL TO ABOVE ROOF.
8. ROUTE 3/4" COPPER DRAIN LINE ALONG WALL FROM HUMIDIFIER AND ELBOW DOWN INTO SINK.
9. SAND TRAP IN FLOOR. SEE DETAILS FOR CONSTRUCTION AND ARCHITECTURAL PLANS FOR EXACT LOCATION.
10. ~~PROVIDE 1" DIA. 2' OF 3/4" DIA. DRAIN AT BASE OF PH~~


DELETE

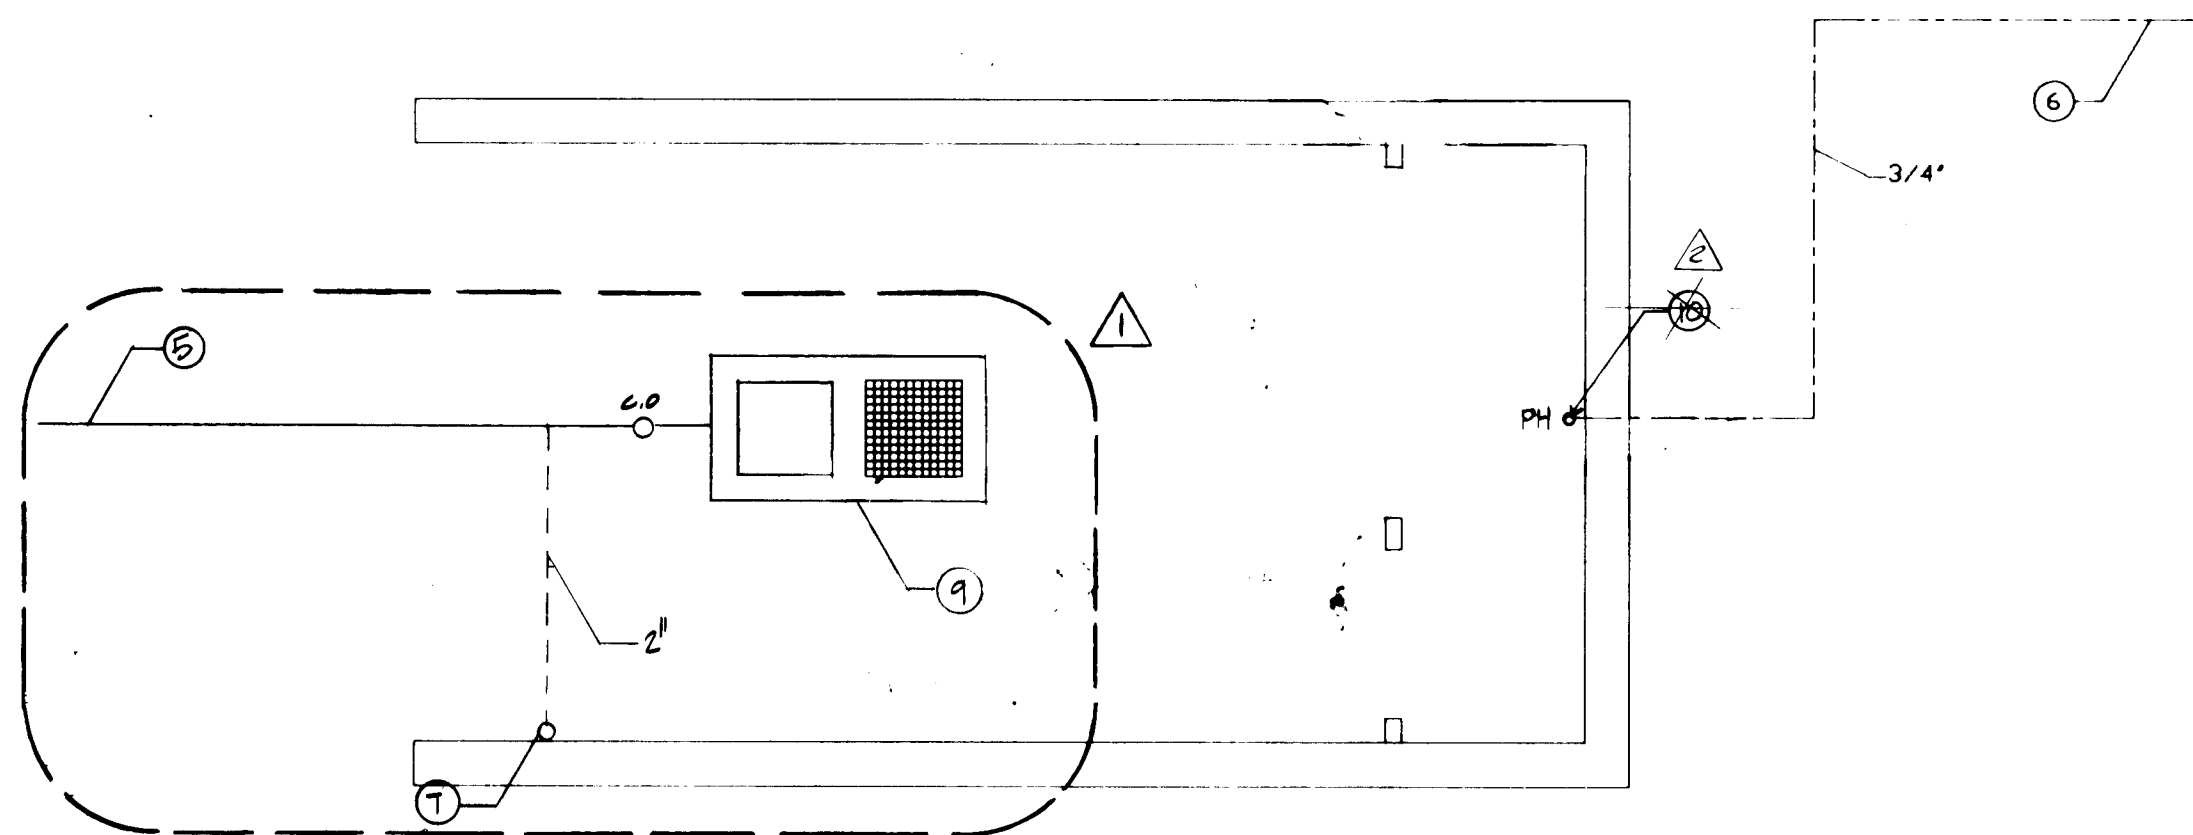

NOTE: PROVIDE AND INSTALL SHVEL MOUNT FOR CAR WASH EQUIPMENT PER MANUFACTURER'S SPECS. CAR WASH EQUIPMENT IS OWNER'S.

CAR WASH PLAN

SCALE: 1/4" = 1'-0"

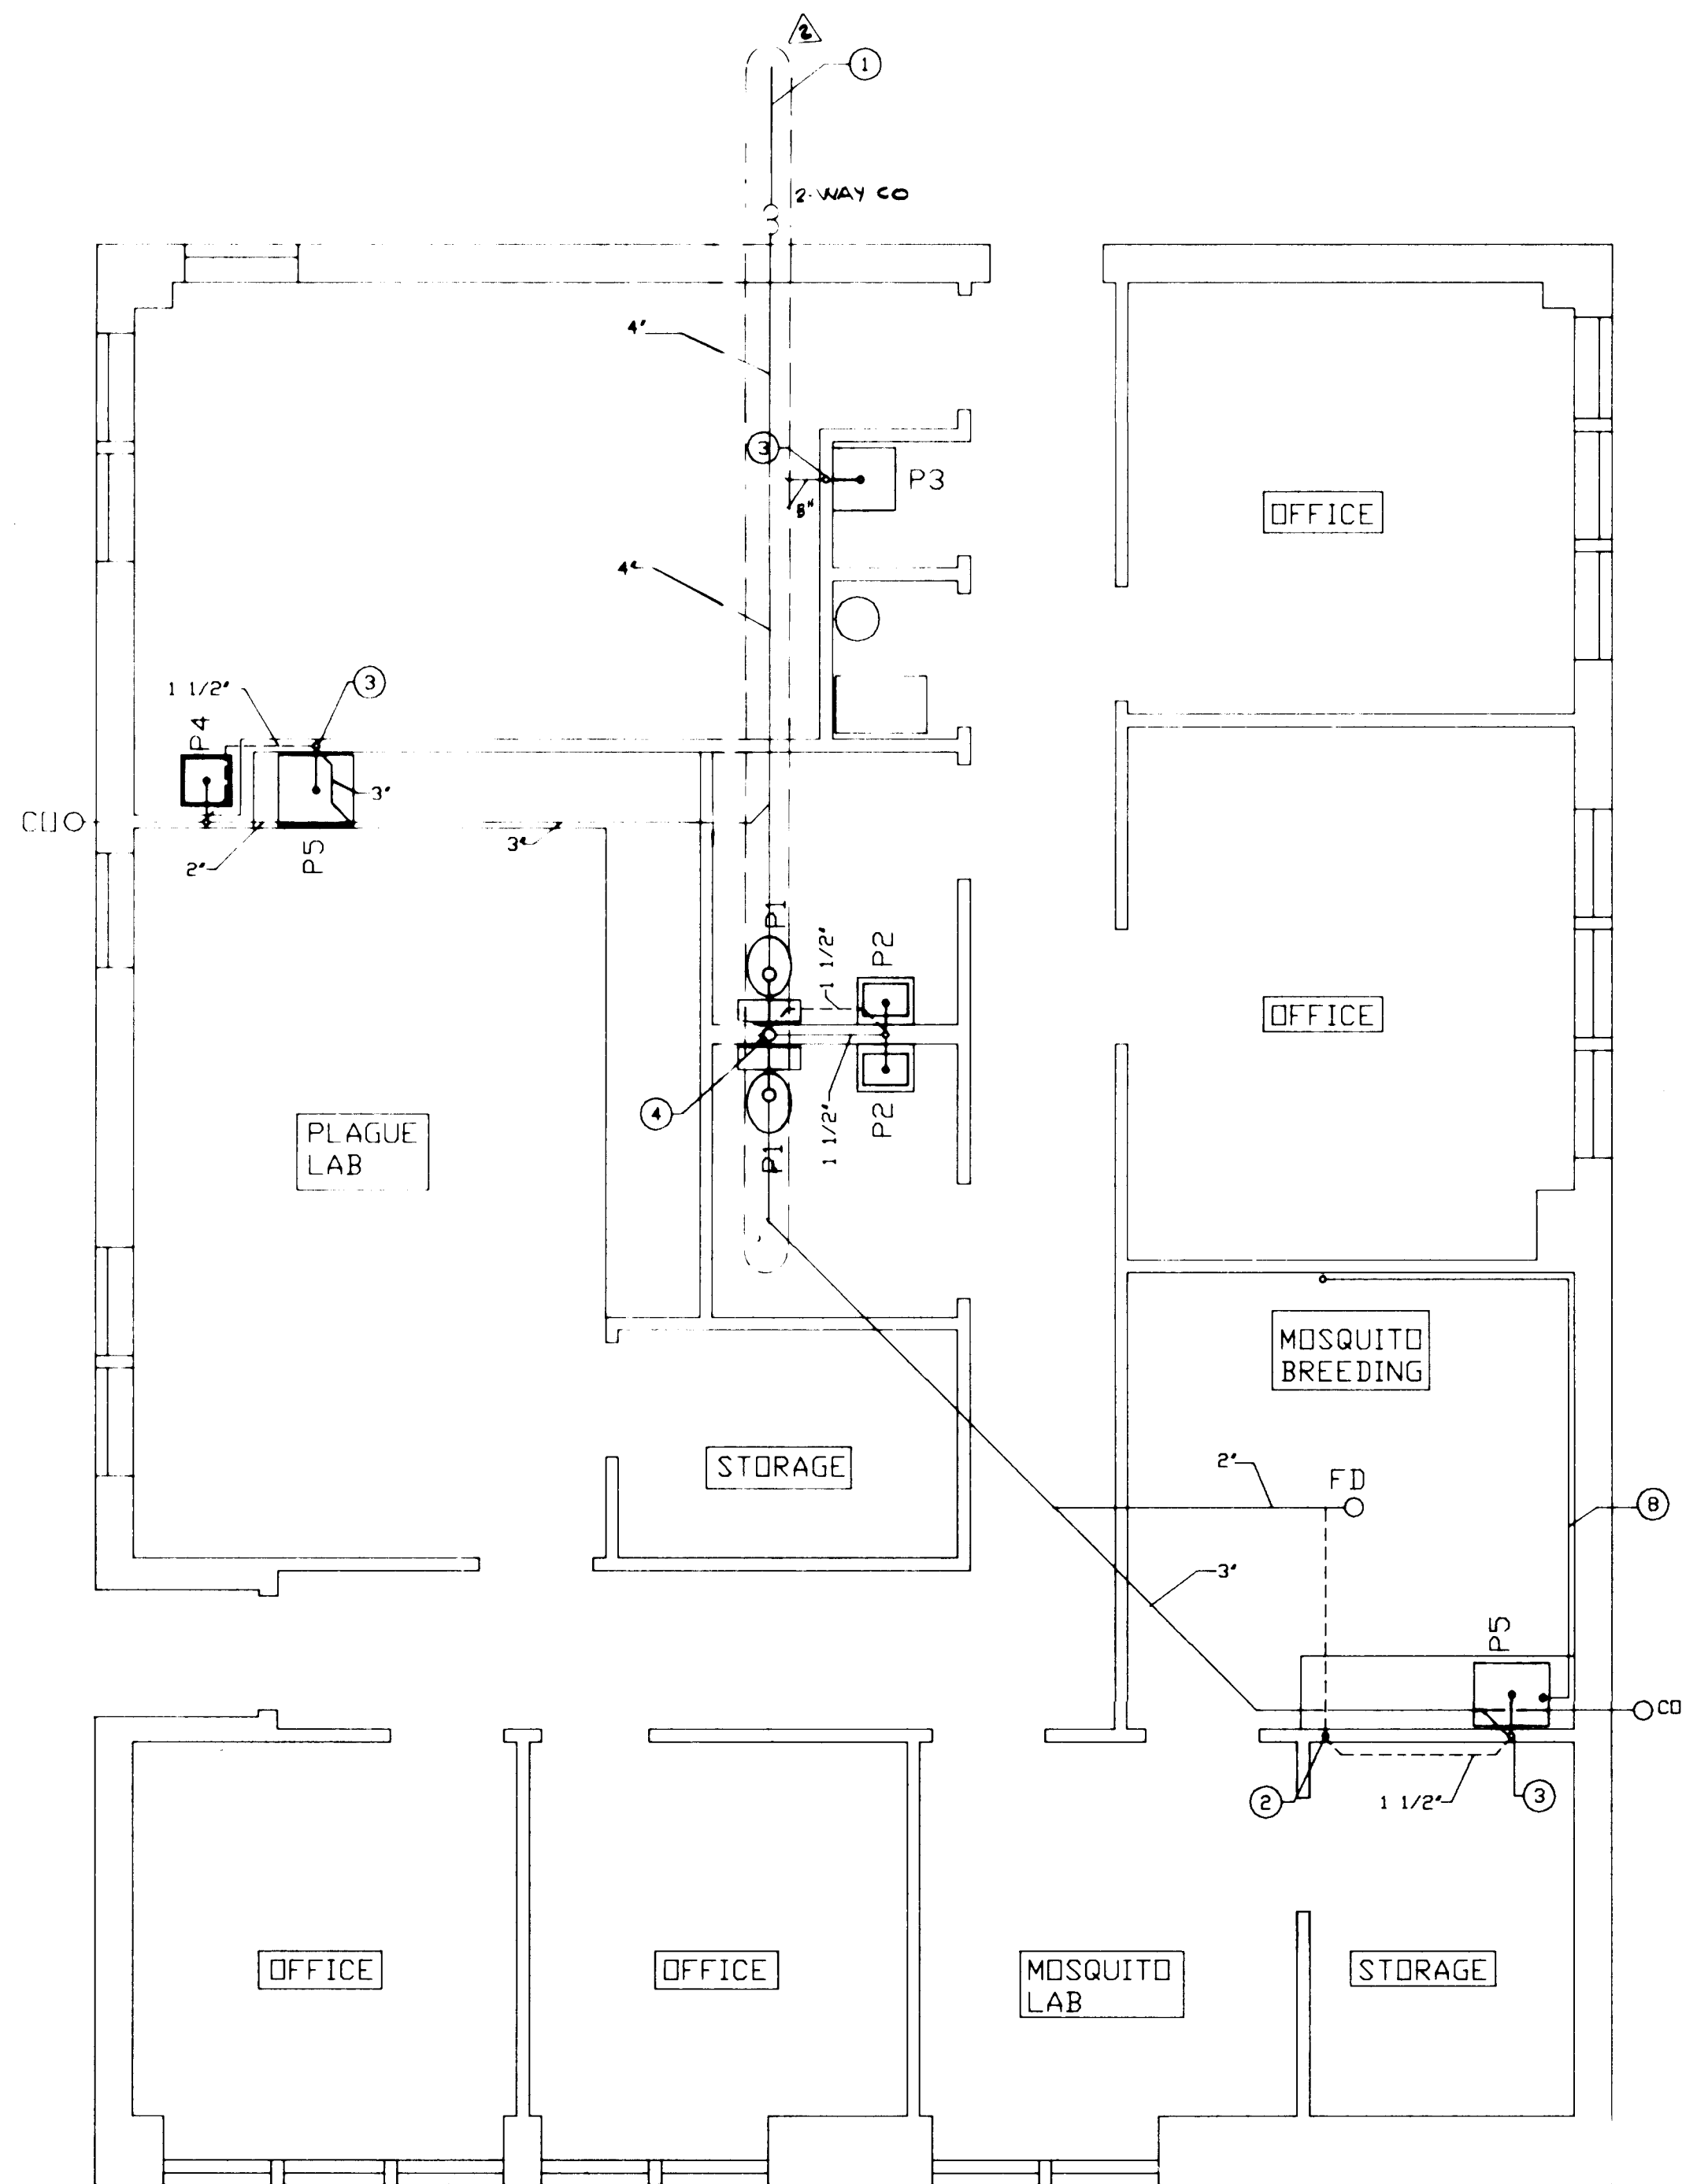

WASTE PIPING PLAN

SCALE: 1/4" = 1'-0"

APPROVAL OF AS BUILT DRAWINGS
Russell B. Smith
DATE 1-12-88

26 28071588




RECORD DRAWING
WASTE PIPING PLANS
CAR WASH
OFFICE / LAB BUILDING

MONTESSA PARK RENOVATION
FOR THE
CITY OF ALBUQUERQUE
ENVIRONMENTAL HEALTH DEPARTMENT

METHON ARCHITECTS GROUP
413 Montecore Drive NE
Albuquerque, NM 87108
505 / 888-8880

DATE: 01/15/88
REV: 01/15/88
10/18/87
PROJECT NUMBER 2807
SHEET 14 OF 17
CARWASH SAND TRAP REVISED
WASTE LINE LOCATION, POST HYDRANT

M3

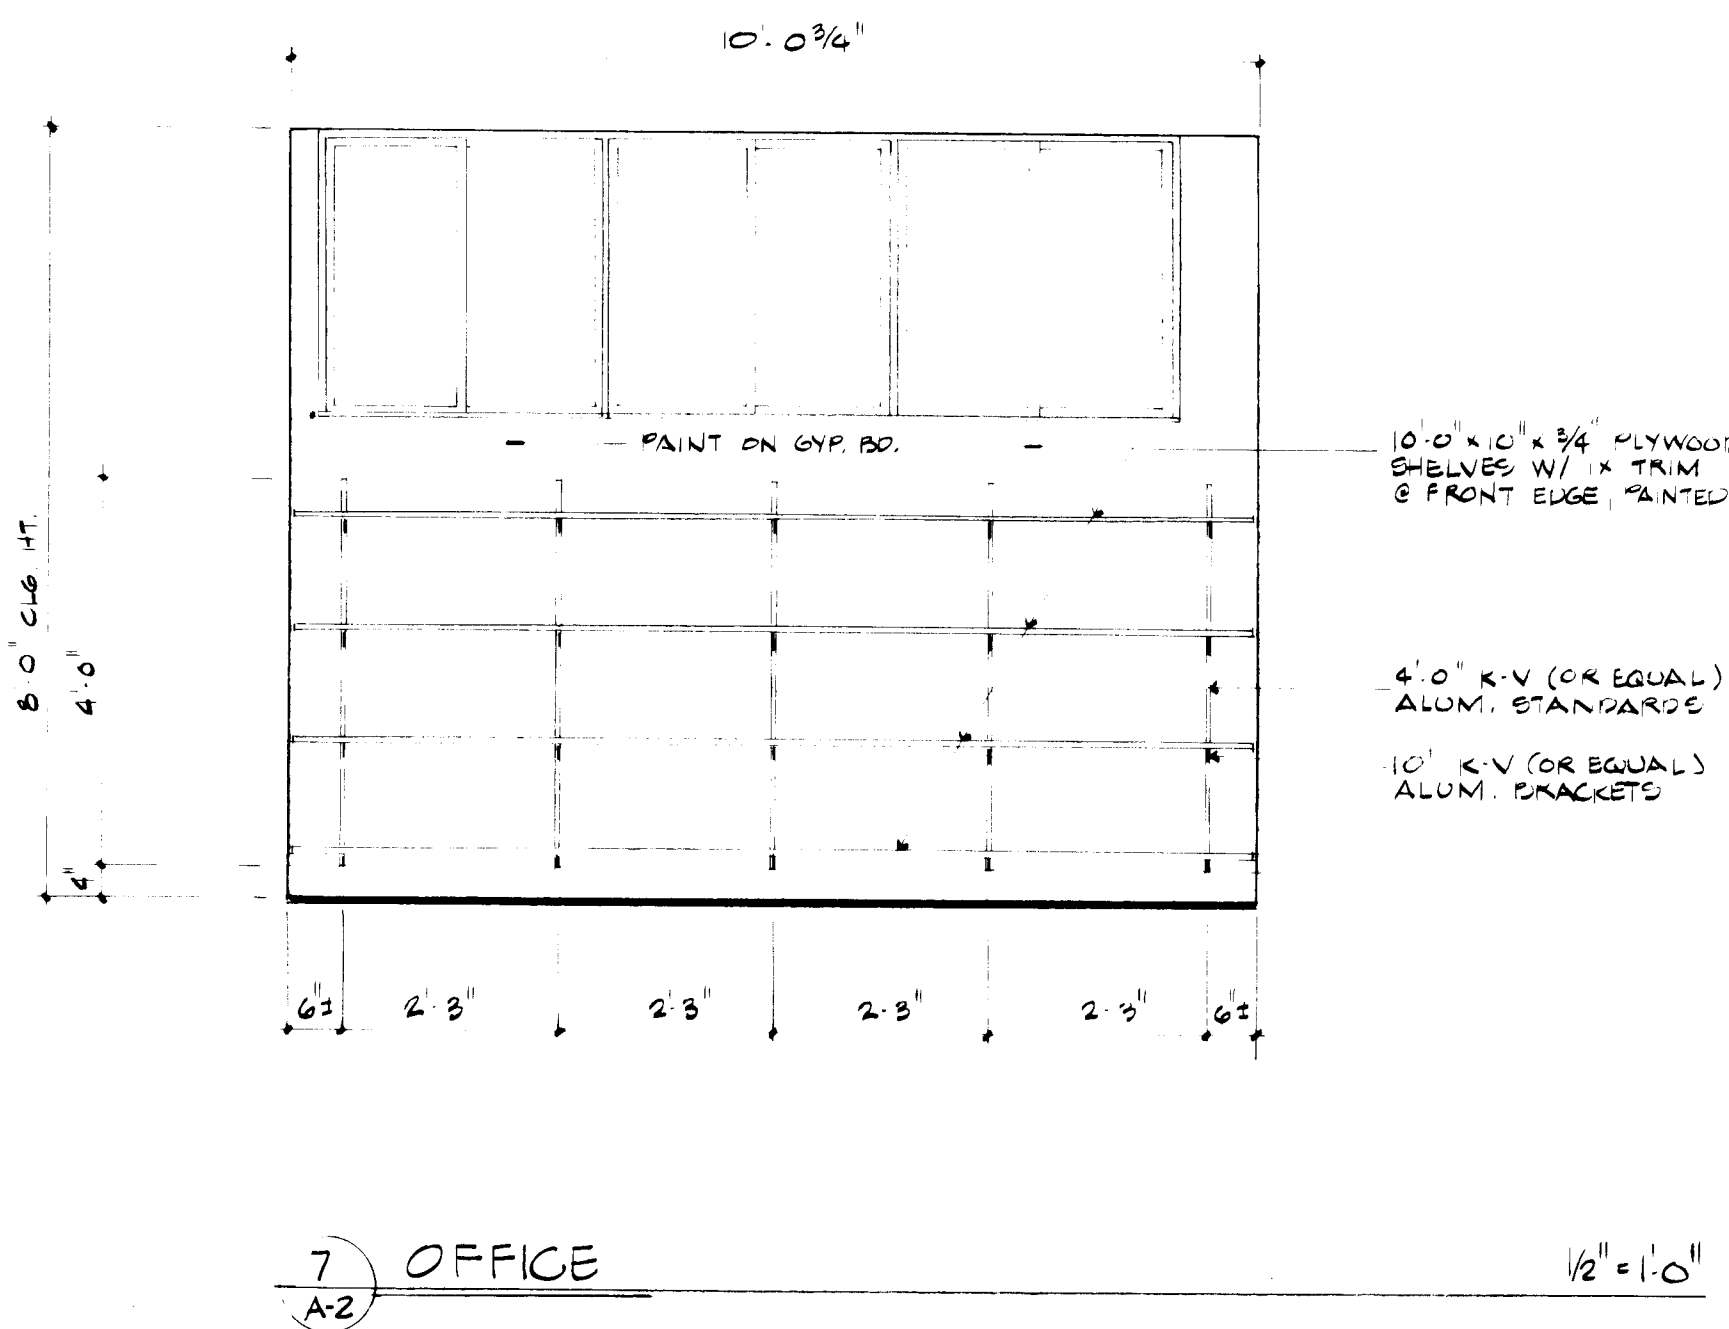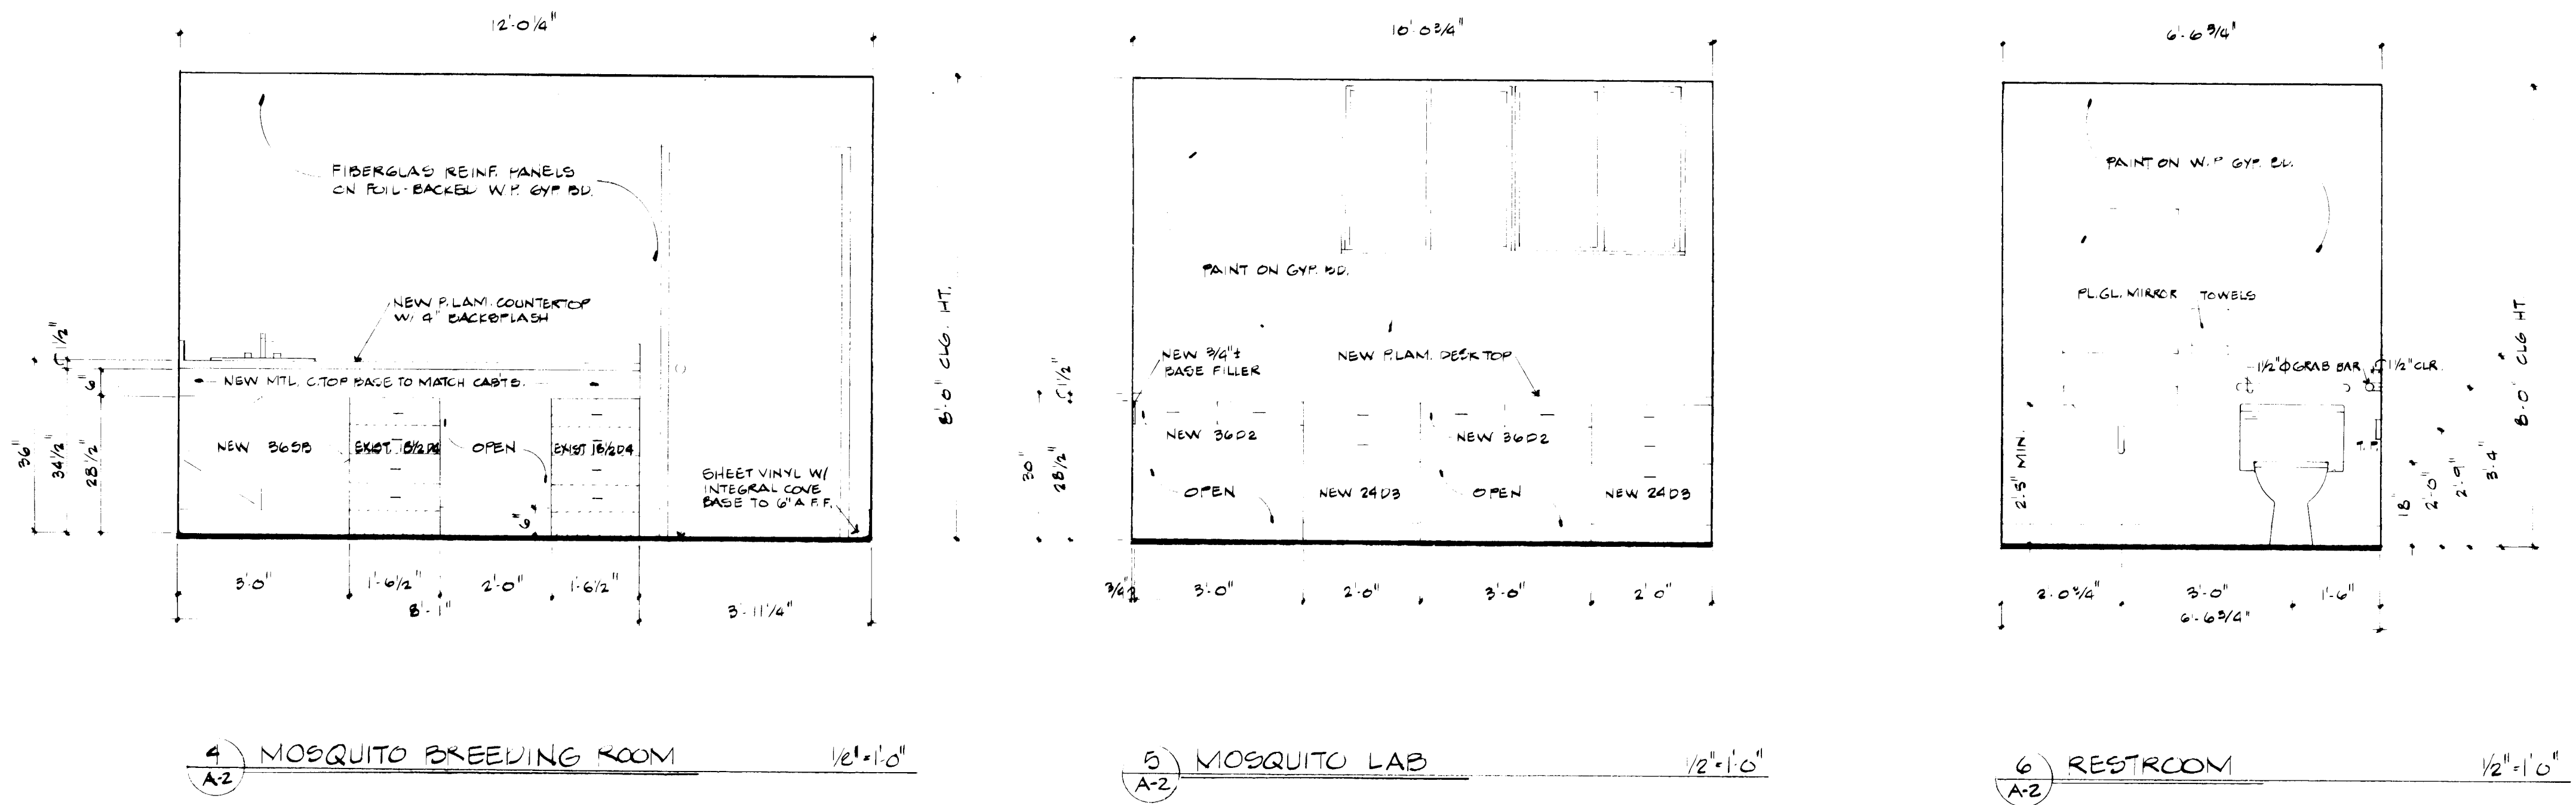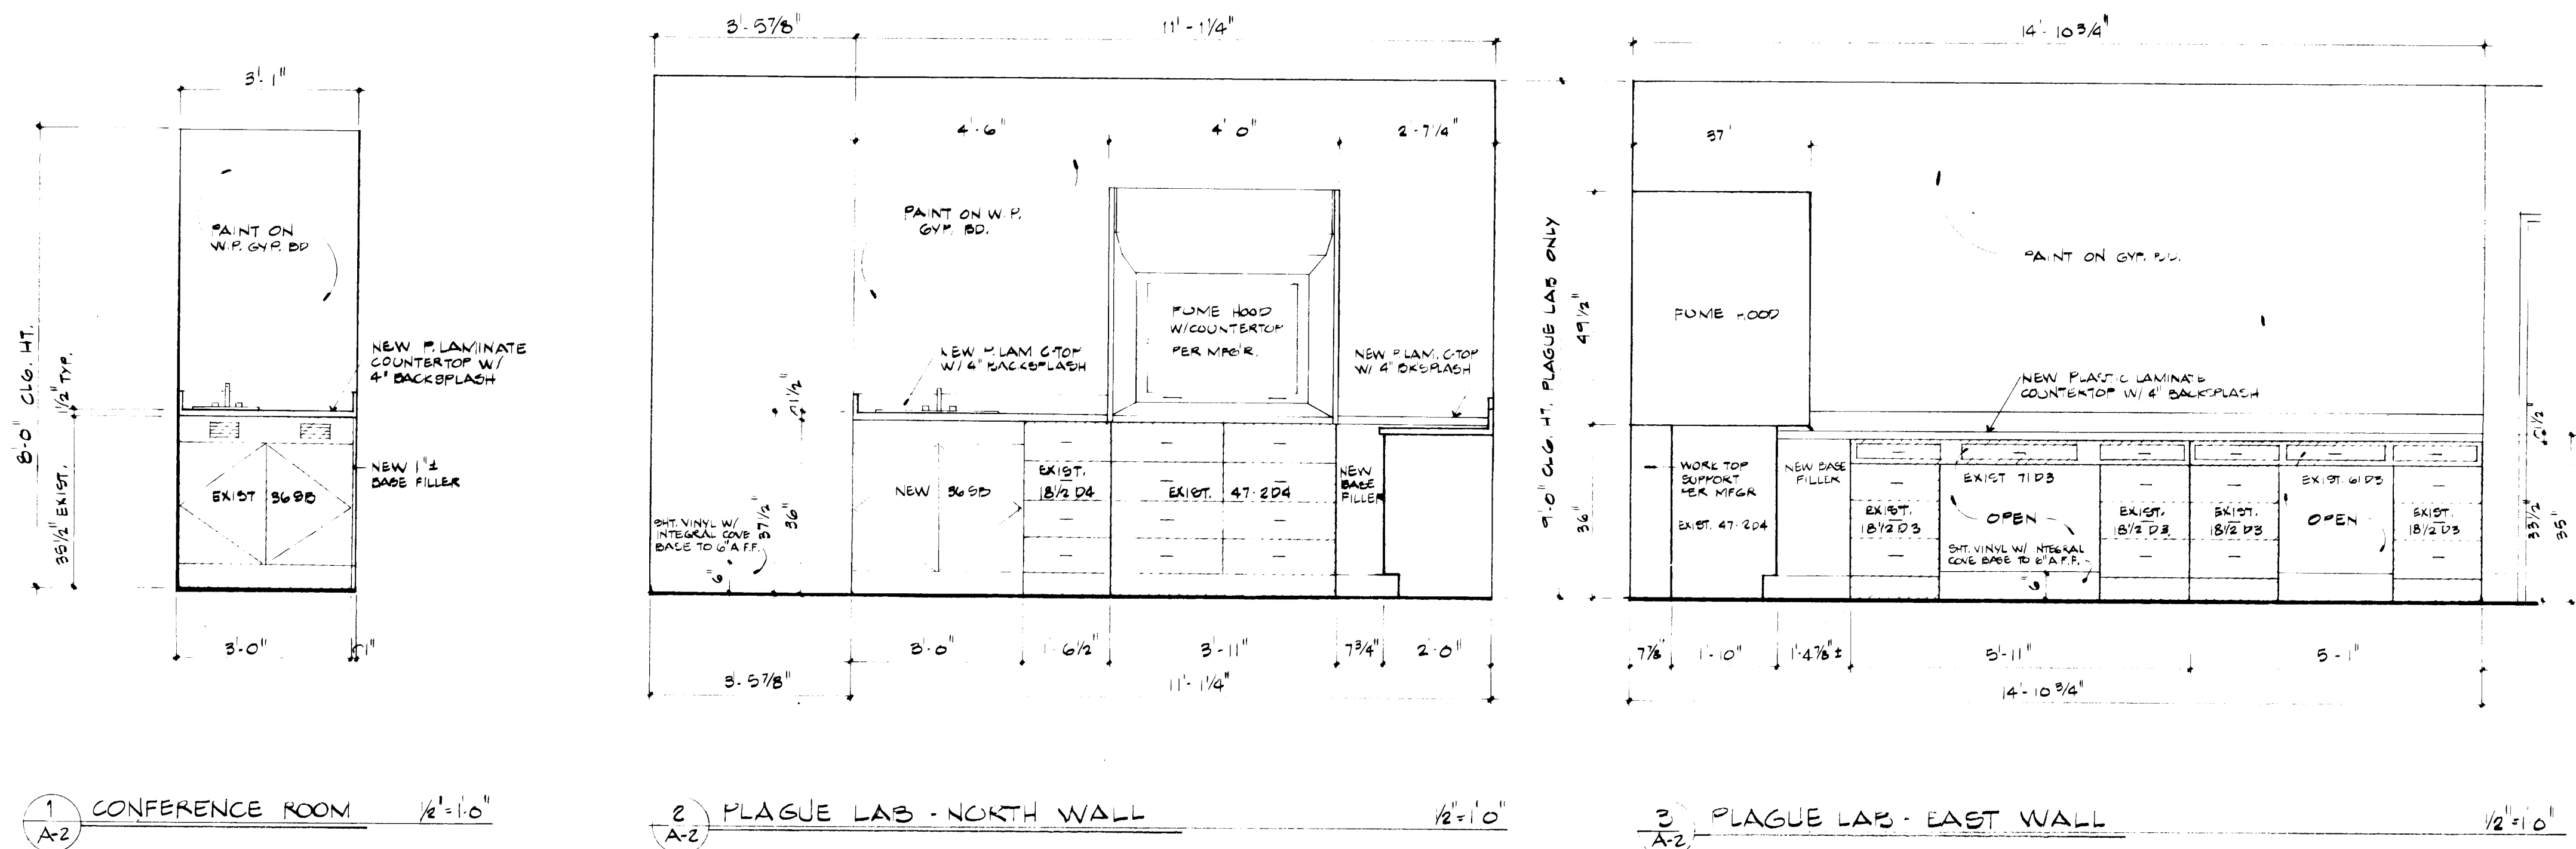


NOTES:

1. DIMENSIONS GIVEN ON INTERIOR ELEVATIONS ARE FINISHED DIMENSIONS. VERIFY ALL DIMENSIONS IN THE FIELD.
2. VERIFY SIZE OF ALL EXISTING CABINETS TO BE REUSED.
3. ALL EXISTING METAL CABINETS TO BE REUSED SHALL BE CLEANED AND MAINTAINED.
4. NEW CABINETS SHALL MATCH EXISTING.

ROOM	FLOOR	BASE	WALL	CEILING	CEILING HT.	REMARKS
1 CONFERENCE						
2 JANITOR CLO.						
3 FURNACE						
4 OFFICE						
5 MEN						
6 WOMEN						
7 PLAGUE LAB						
8 STORAGE						
9 OFFICE						
10 MOSQ. BREED.						
11 STORAGE						
12 MOSQUITO LAB						
13 OFFICE						
14 OFFICE						
15 HALL						

SIZE	FRAME	TYPE	GLAZING	REMARKS
A 3'0" x 3'0"	ALUM.	SLIDER	DOUBLE	PER BLDG. MFR.
B 2'6" x 3'0"	ALUM.	SLIDER	DOUBLE	PER BLDG. MFR.
C 3'6" x 3'0"	ALUM.	SLIDER	DOUBLE	PER BLDG. MFR.

NO.	SIZE	TYPE	H	WARE	FRAME	THRESHOLD	REMARKS
1	3'0" x 7'0" x 1 3/4"	A	1	*			* PER BLDG. MFR.
2	3'0" x 6'8" x 1 3/4"	B	1	2" H.M.			
3	3'0" x 6'8" x 1 3/8"	C	2	WOOD			BIFOLD
4	3'0" x 6'8" x 1 3/8"	D	3	2" H.M.			
5	3'0" x 6'8" x 1 3/4"	B	3				
6	3'0" x 6'8" x 1 3/8"	C	4				INSTALL SIGN
7	3'0" x 6'8" x 1 3/4"	E	3				
8	3'0" x 6'8" x 1 3/8"	L	4				INSTALL SIGN
9	3'0" x 6'8" x 1 3/4"	A	3				W/ DOOR BOTTOM SEAL
10	3'0" x 6'8" x 1 3/8"	E	3				
11	3'0" x 6'8" x 1 3/4"	B	5				
12	3'0" x 6'8" x 1 3/4"	B	3				
13	3'0" x 6'8" x 1 3/4"	B	3				
14	3'0" x 6'8" x 1 3/8"	B	5				
15	3'0" x 6'8" x 1 3/4"	B	3				
16	3'0" x 7'0" x 1 3/4"	A	1	*			* PER BLDG. MFR.

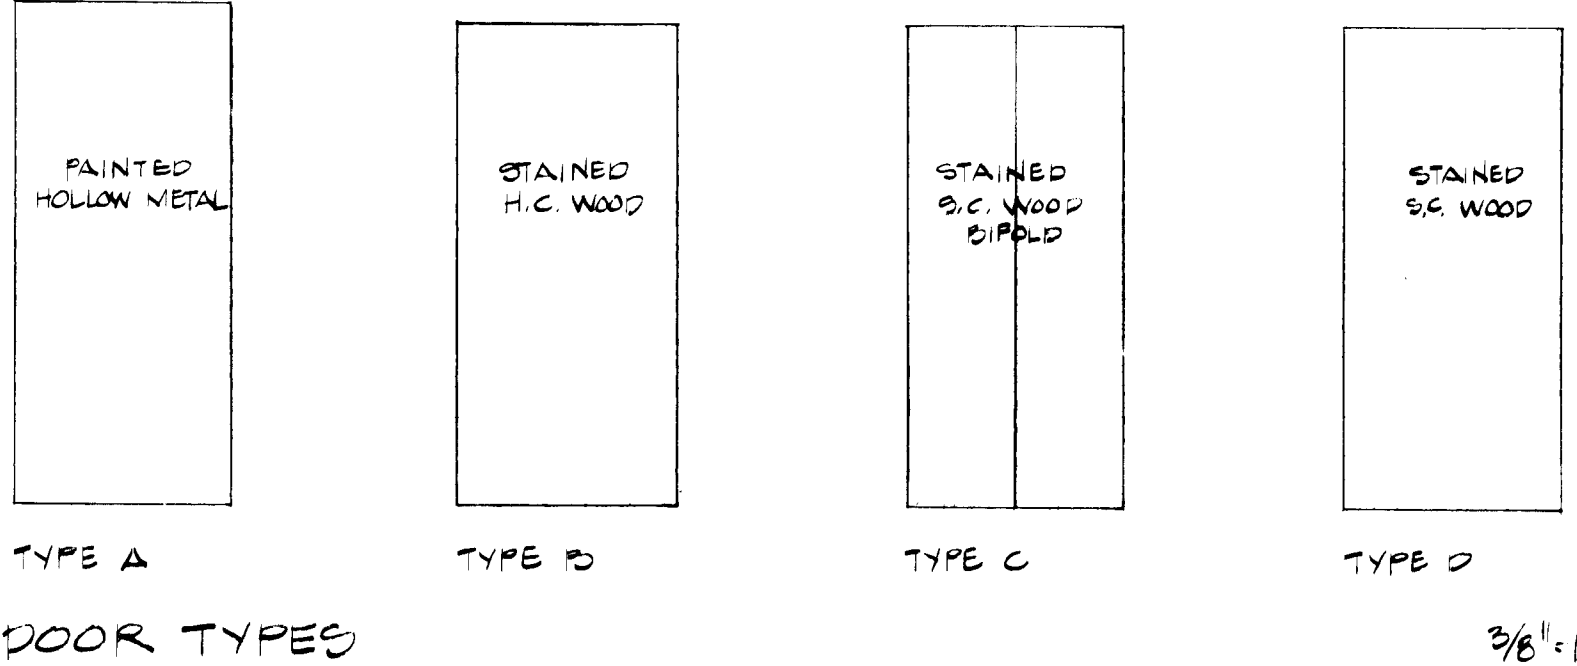

FIXTURE SCHEDULE


- P1 **WATER CLOSET:** AMERICAN STANDARD MODEL 2108.408, RIM HEIGHT AT 18" AFF, COMPLETE WITH TANK AND WATER SAVER TRIM, BOLT CAPS, SUPPLY STOP AND WHITE PLASTIC SEAT. 4" WASTE, 2" OR 4" VENT, 1/2" CW.
- P2 **LAUATORY:** AMERICAN STANDARD MODEL 0373.027, WITH WALL HANGER AND RIM MOUNTED AT 31" AFF. PROVIDE WITH SINGLE HANDLE FAUCET, P-TRAP, AND SUPPLY STOPS. INSULATE P-TRAP AND HW SUPPLY WITH 1" FIBERGLASS WITH ALUMINUM PROTECTIVE COVERING. 1 1/2" WASTE, 1 1/2" VENT, 1/2" CW, 1/2" HW.
- P3 **SERVICE SINK:** AMERICAN STANDARD NO. 7692.049, WITH NO 8341.075 TRIM, RIM GUARD, WALL HANGER, AND STANDARD TRAP. 2" WASTE, 1 1/2" VENT, 1/2" CW, 1/2" HW.
- P4 **SINK:** ELKAY MODEL LR-1517, 15" X 17" X 7" DEEP, 18 GAUGE, TYPE 304 STAINLESS STEEL WITH SOUND DAMPERING, SELF RIMMING, P-TRAP, CRUMB CUP STRAINER, SINGLE FAUCET HOLE, LK-2088-13 GOOSENECK FAUCET. 1 1/2" WASTE, 1 1/2" VENT, 1/2" CW, 1/2" HW.
- P5 **SINK:** ELKAY MODEL DLR-3122-12, 28" X 16" X 11" DEEP, 18 GAUGE, 302 STAINLESS STEEL, SELF RIMMING, WITH P-TRAP, CRUMB CUP STRAINER, AND LK-4102 FAUCET. 1 1/2" WASTE, 1 1/2" VENT, 1/2" CW, 1/2" HW.
- P6 **WATER HEATER:** AO SMITH MODEL NO. PGC-50, NATURAL GAS FIRED WATER HEATER ORFICED FOR 5000' ELEVATION. 40,000 BTUH INPUT, 50 GALLON STORAGE CAPACITY, GLASS LINED TANK WITH MAGNESIUM ANODE, T & P RELIEF VALVE, AND 3" DIA. FLUE.
- P7 **GAS COCK:** CHICAGO FAUCET NO. 907

- HB **HOSE BIB:** SMITH FIG. 5509 FREEZEPROOF HOSE BIB WITH VACUUM BREAKER
- FD **FLOOR DRAIN:** SMITH FIG. 2010-A WITH 5" DIA ADJUSTABLE POLISHED BRONZE TOP, AND VANDEL PROOF SCREWS.
- PH **POST HYDRANT:** SMITH MODEL 5910 WITH 3/4" HOSE CONNECTION. VACUUM BREAKER, CAST IRON CASING GUARD AND REMOVABLE "T" HANDLE.
- CO **CLEANOUT:** (FOR APPLICABLE FINISH)
- A. CONCRETE, CERAMIC TILE, OR QUARRY TILE: SMITH FIG. 4023
- B. VINYL TILE OR ASBESTOS TILE: SMITH FIG 4143
- C. CARPET: SMITH FIG. 4023-Y WITH CARPET MARKER.

SPECIFIC NOTES - WATER AND GAS PIPING PLAN

1. SHUT OFF VALVE IN VALVE BOX. SEE SITE PLAN FOR CONTINUATION.
2. 1" CW UP FROM BELOW GRADE. ROUTE UP TO CEILING SPACE.
3. HW AND CW LINES IN CEILING SPACE.
4. 3/4" CW WITH SHUT-OFF VALVE AND UNION TO WATER HEATER INLET. 3/4" HW WITH UNION TO WATER HEATER OUTLET. ROUTE 3/4" T & P RELIEF LINE TO SERVICE SINK.
5. 3/4" CW AND 1/2" HW DOWN INTO PLUMBING WALL AND ROUTE TO FIXTURE.
6. 1/2" CW DOWN IN WALL TO HUMIDIFIER WITH SHUT-OFF VALVE.
7. 1/2" HW AND 3/4" CW DOWN IN WALL TO FIXTURE. ROUTE 3/4" CW TO HB.
8. 1/2" HW AND 1/2" CW DOWN IN WALL TO FIXTURE.
9. GAS METER AND PRESSURE REGULATOR BY UTILITY COMPANY. ALL FEES PAID BY CONTRACTOR. SIZE FOR A TOTAL CONNECTED LOAD OF 150,000 BTUH.
10. 3/4" GAS LINE UP IN WALL TO ABOVE CEILING.
11. 3/4" GAS LINE FROM CEILING. ROUTE TO FURNACE AND WATER HEATER WITH SHUT-OFF VALVE, DIRT LEG, AND FLEX CONNECTION AT EACH APPLIANCE.
12. 1/2" GAS LINE DOWN IN WALL TO P7 AT 6" ABOVE COUNTER.
13. 1/4" CW UP THRU ROOF AND ROUTE TO EVAPORATIVE COOLER. SEE DETAIL.

NOTE: PLACE WATER PIPES BETWEEN CEILING AND 12" R-19 INSULATION OR INSULATE PIPES PER SPECS.

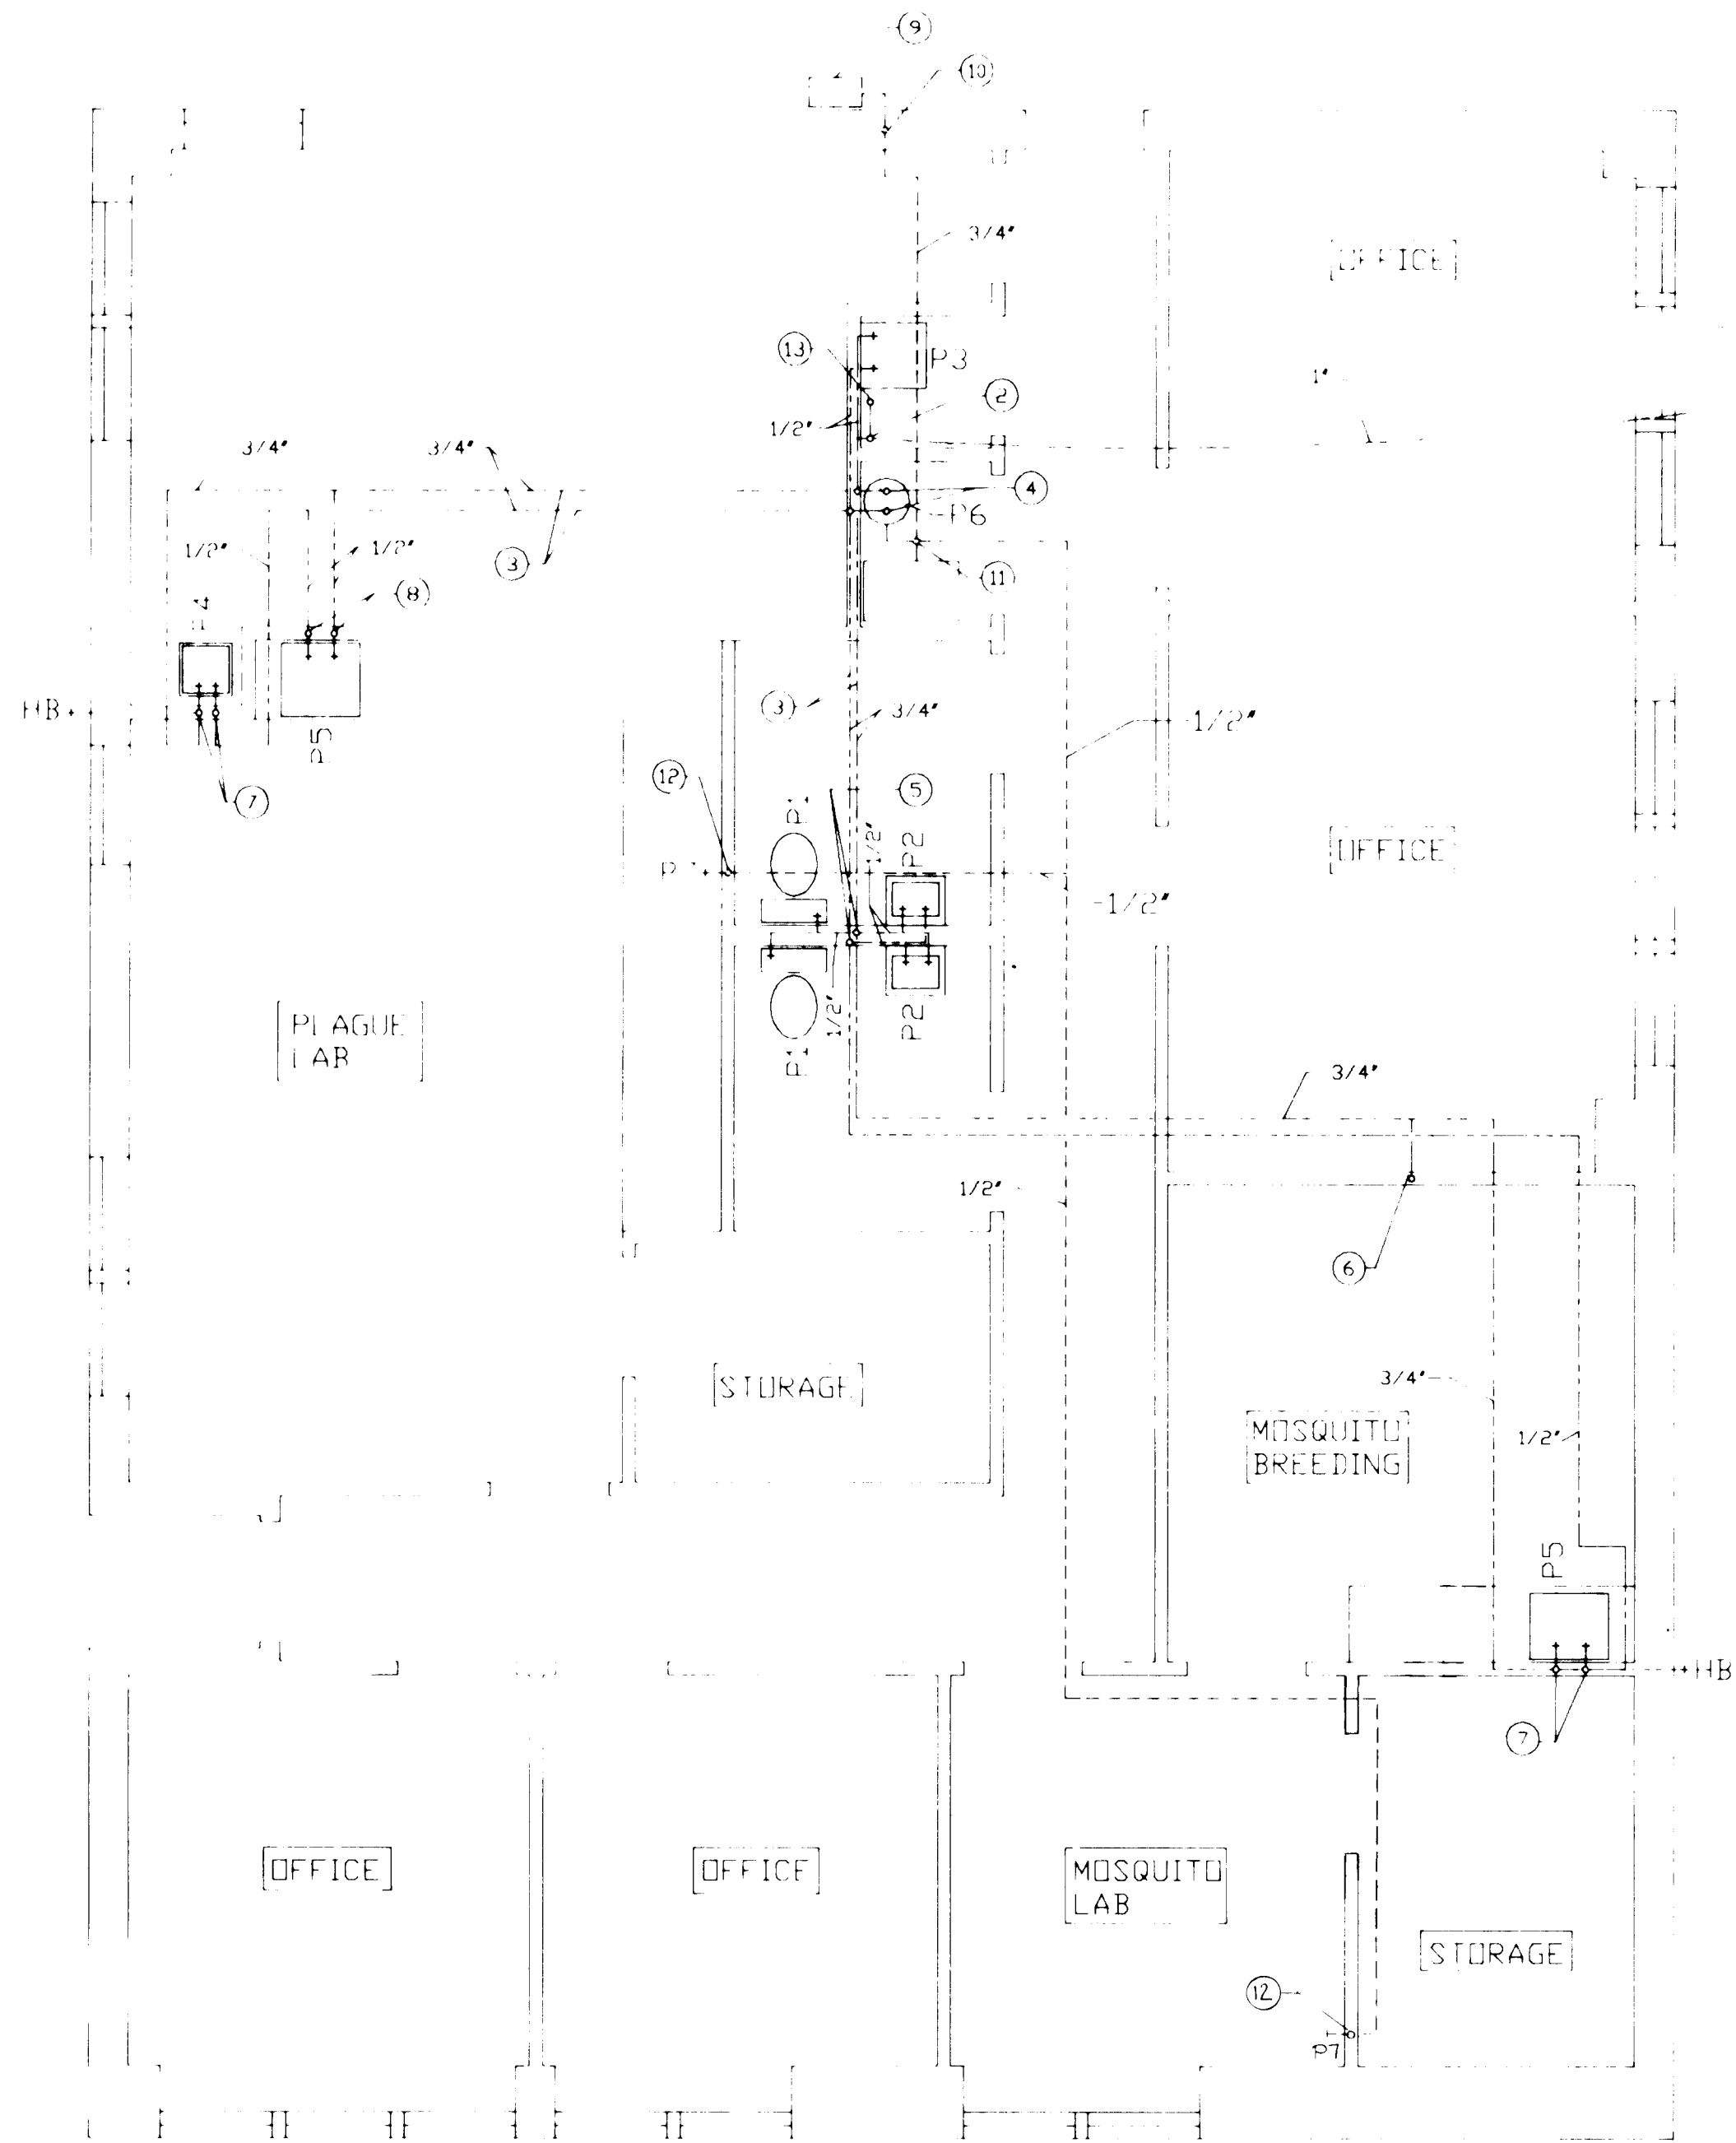


WATER & GAS PIPING PLAN

SCALE: 1/4" = 1'-0"



APPROVAL OF AS BUILT DRAWINGS
DATE 1-12-88
Russell B. Smith

RECORD DRAWING for as built drawings
DATE 1-12-88
Russell B. Smith


26 28071688

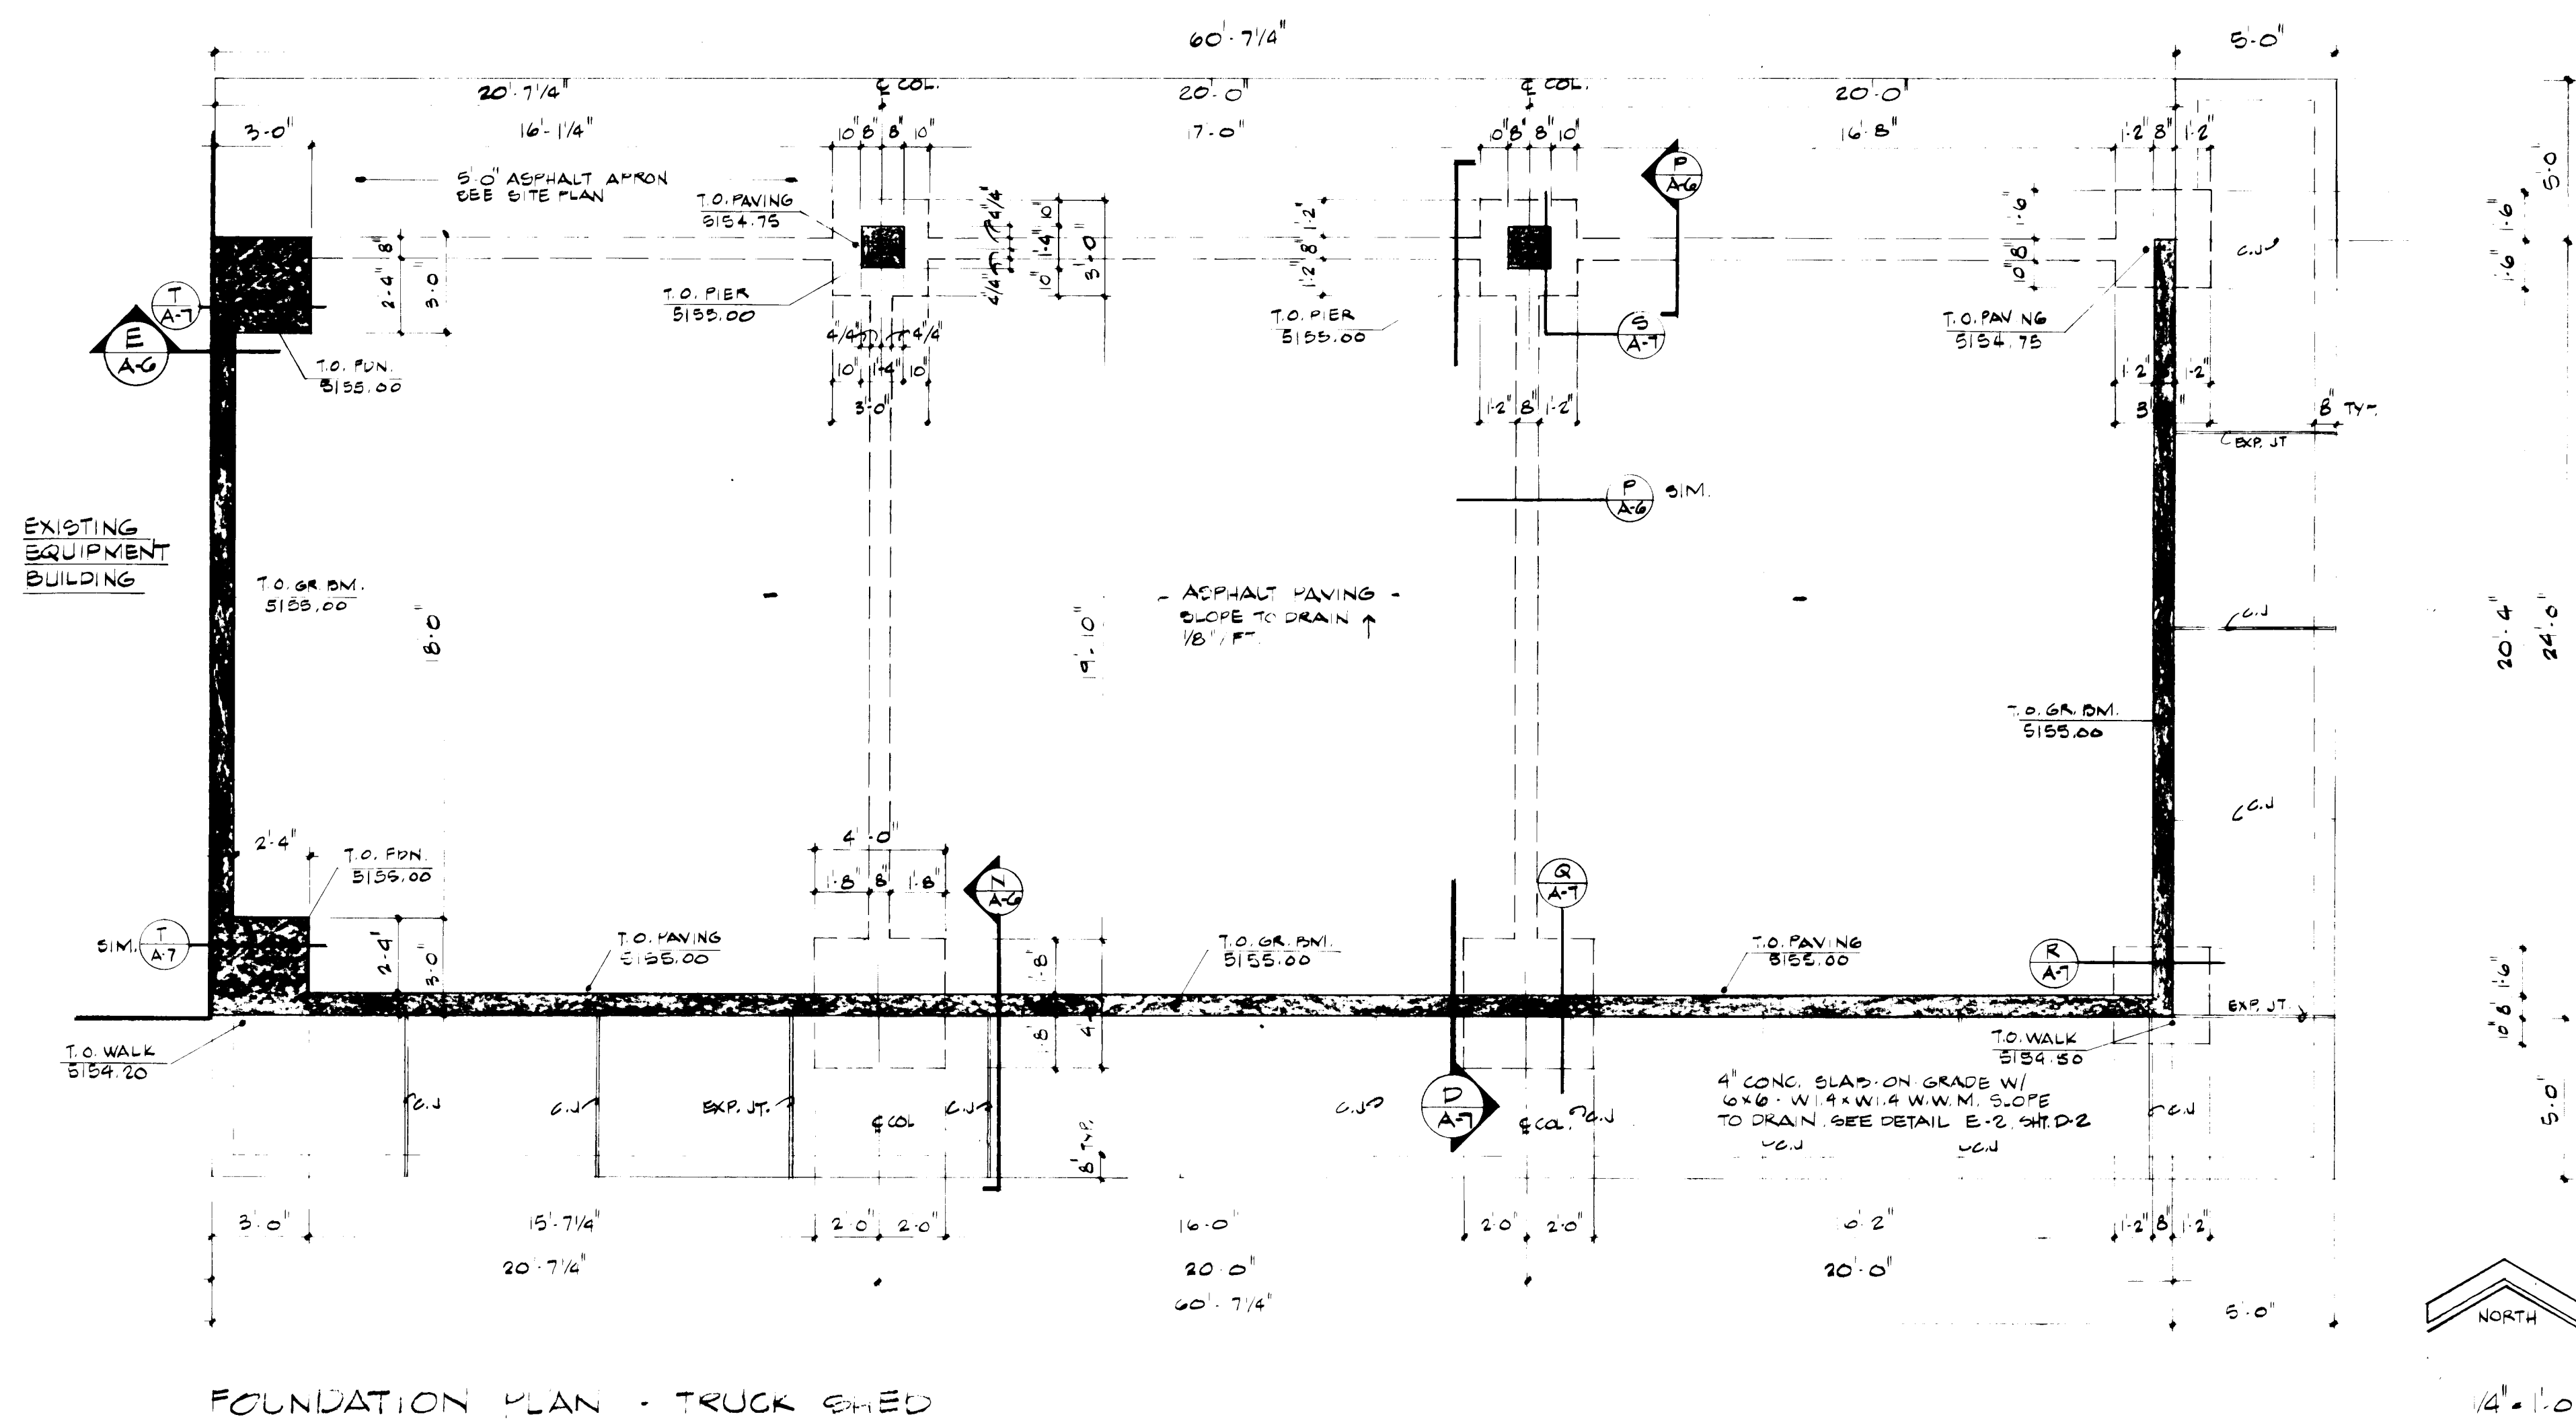

FOUNDATION PLAN - TRUCK SHED

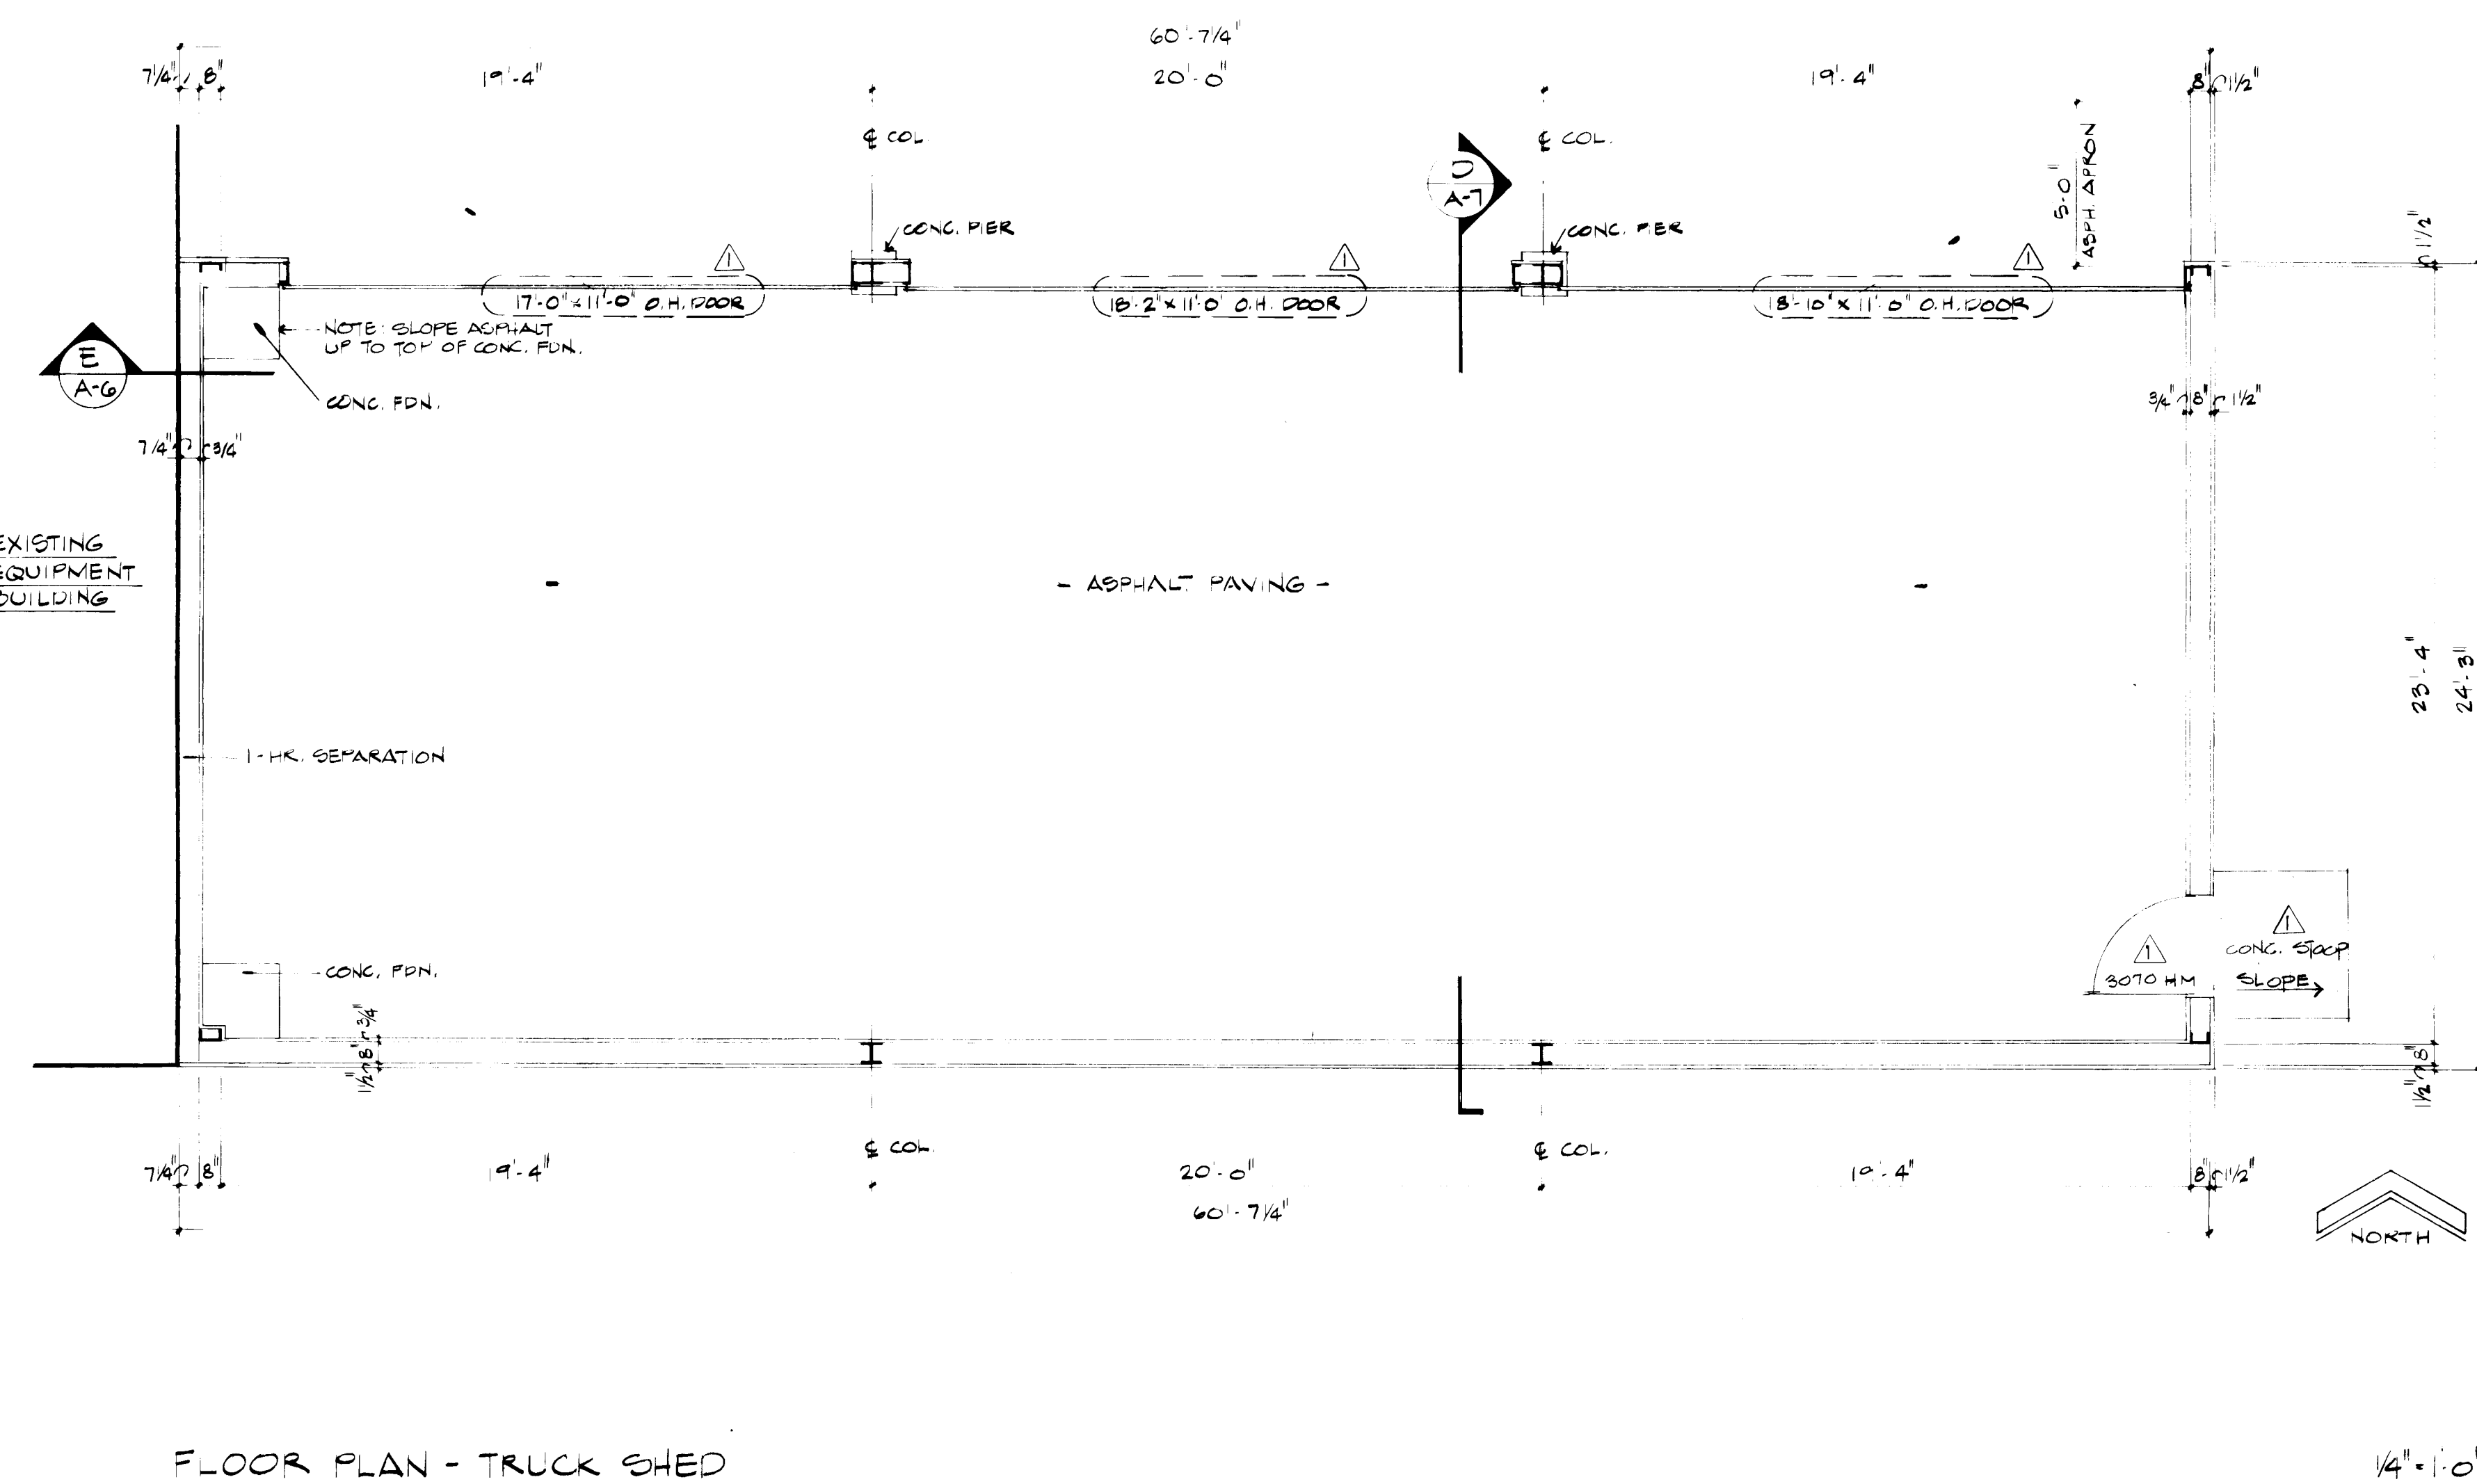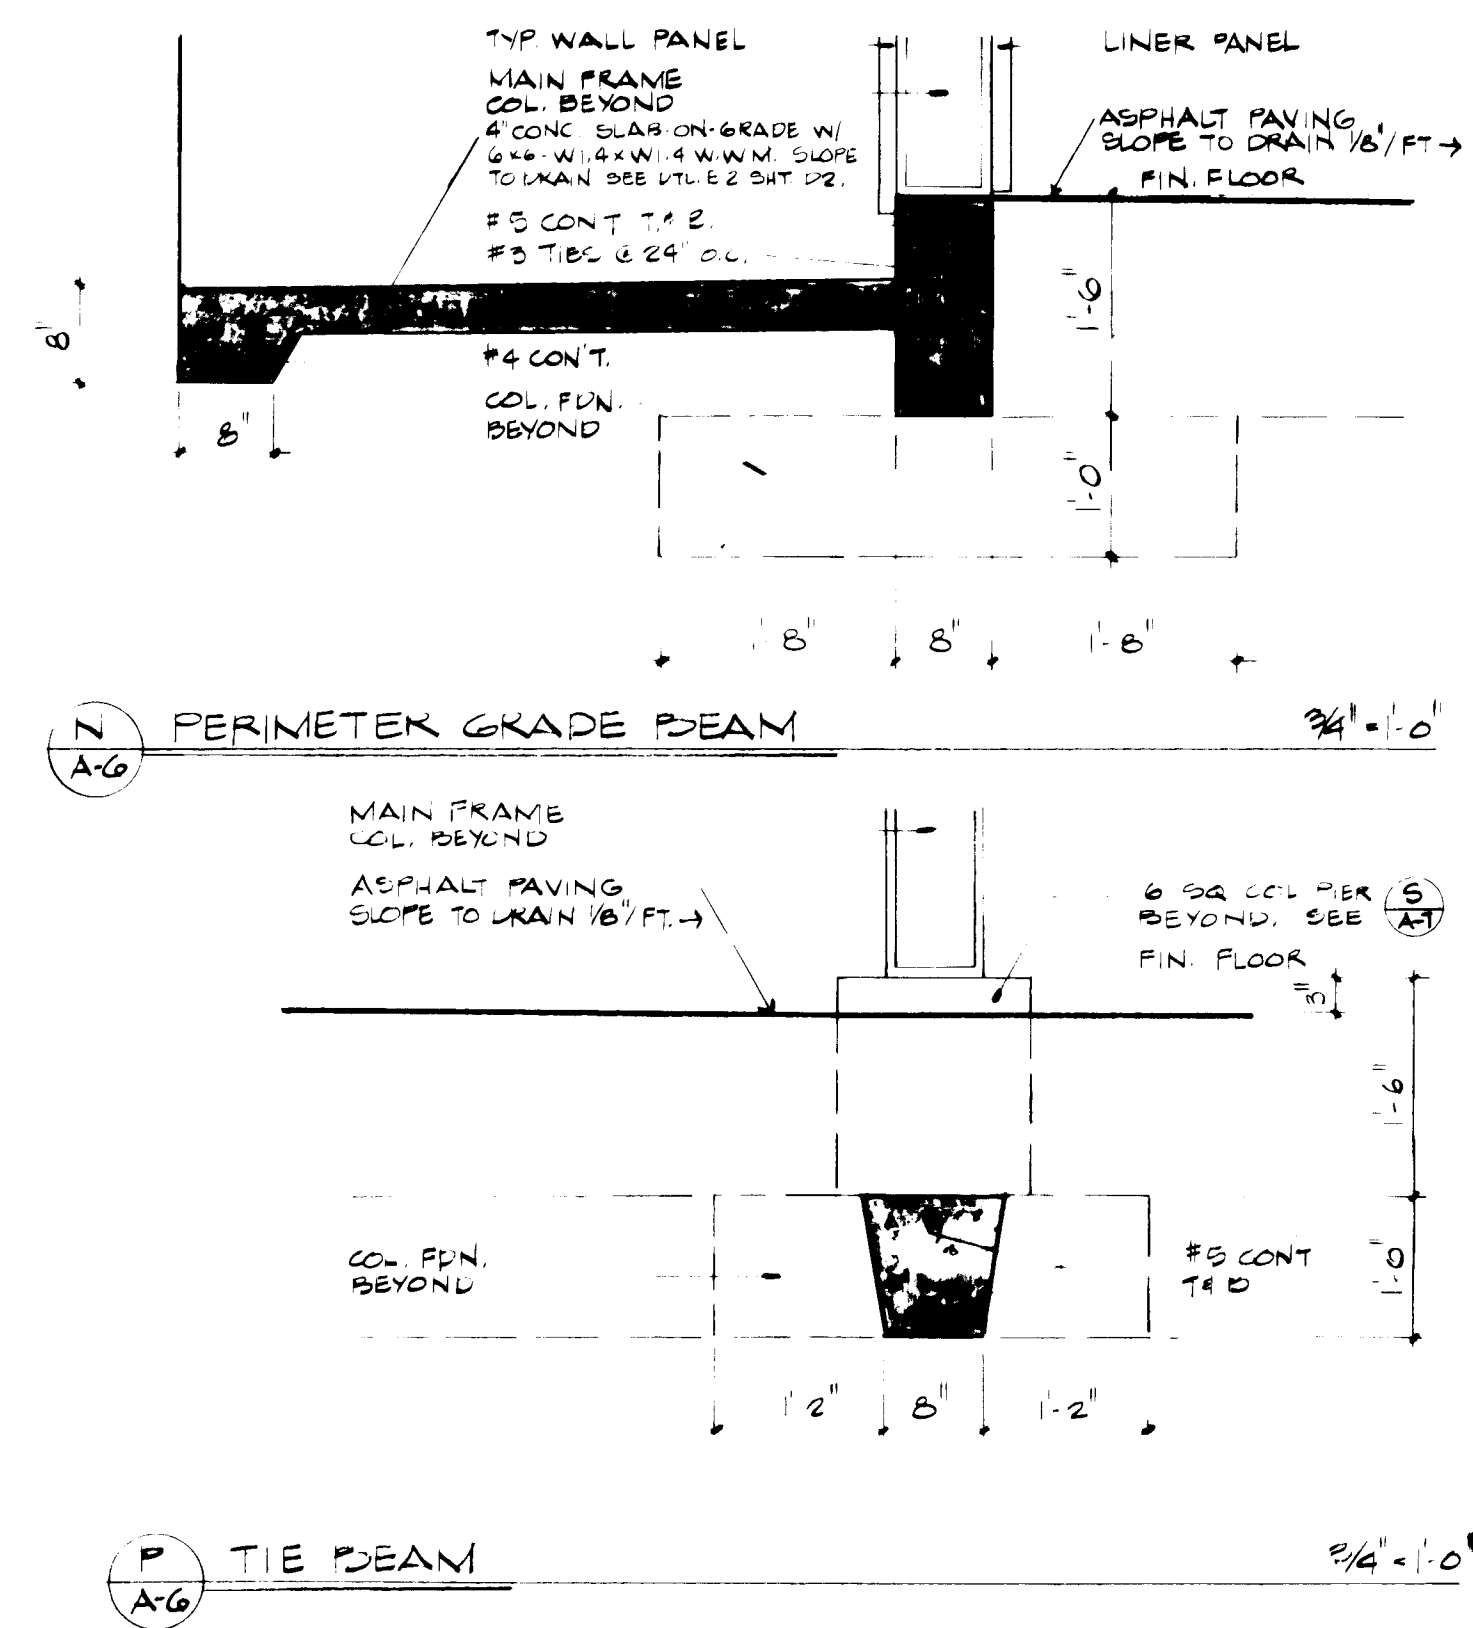





FLOOR PLAN - TRUCK SHED

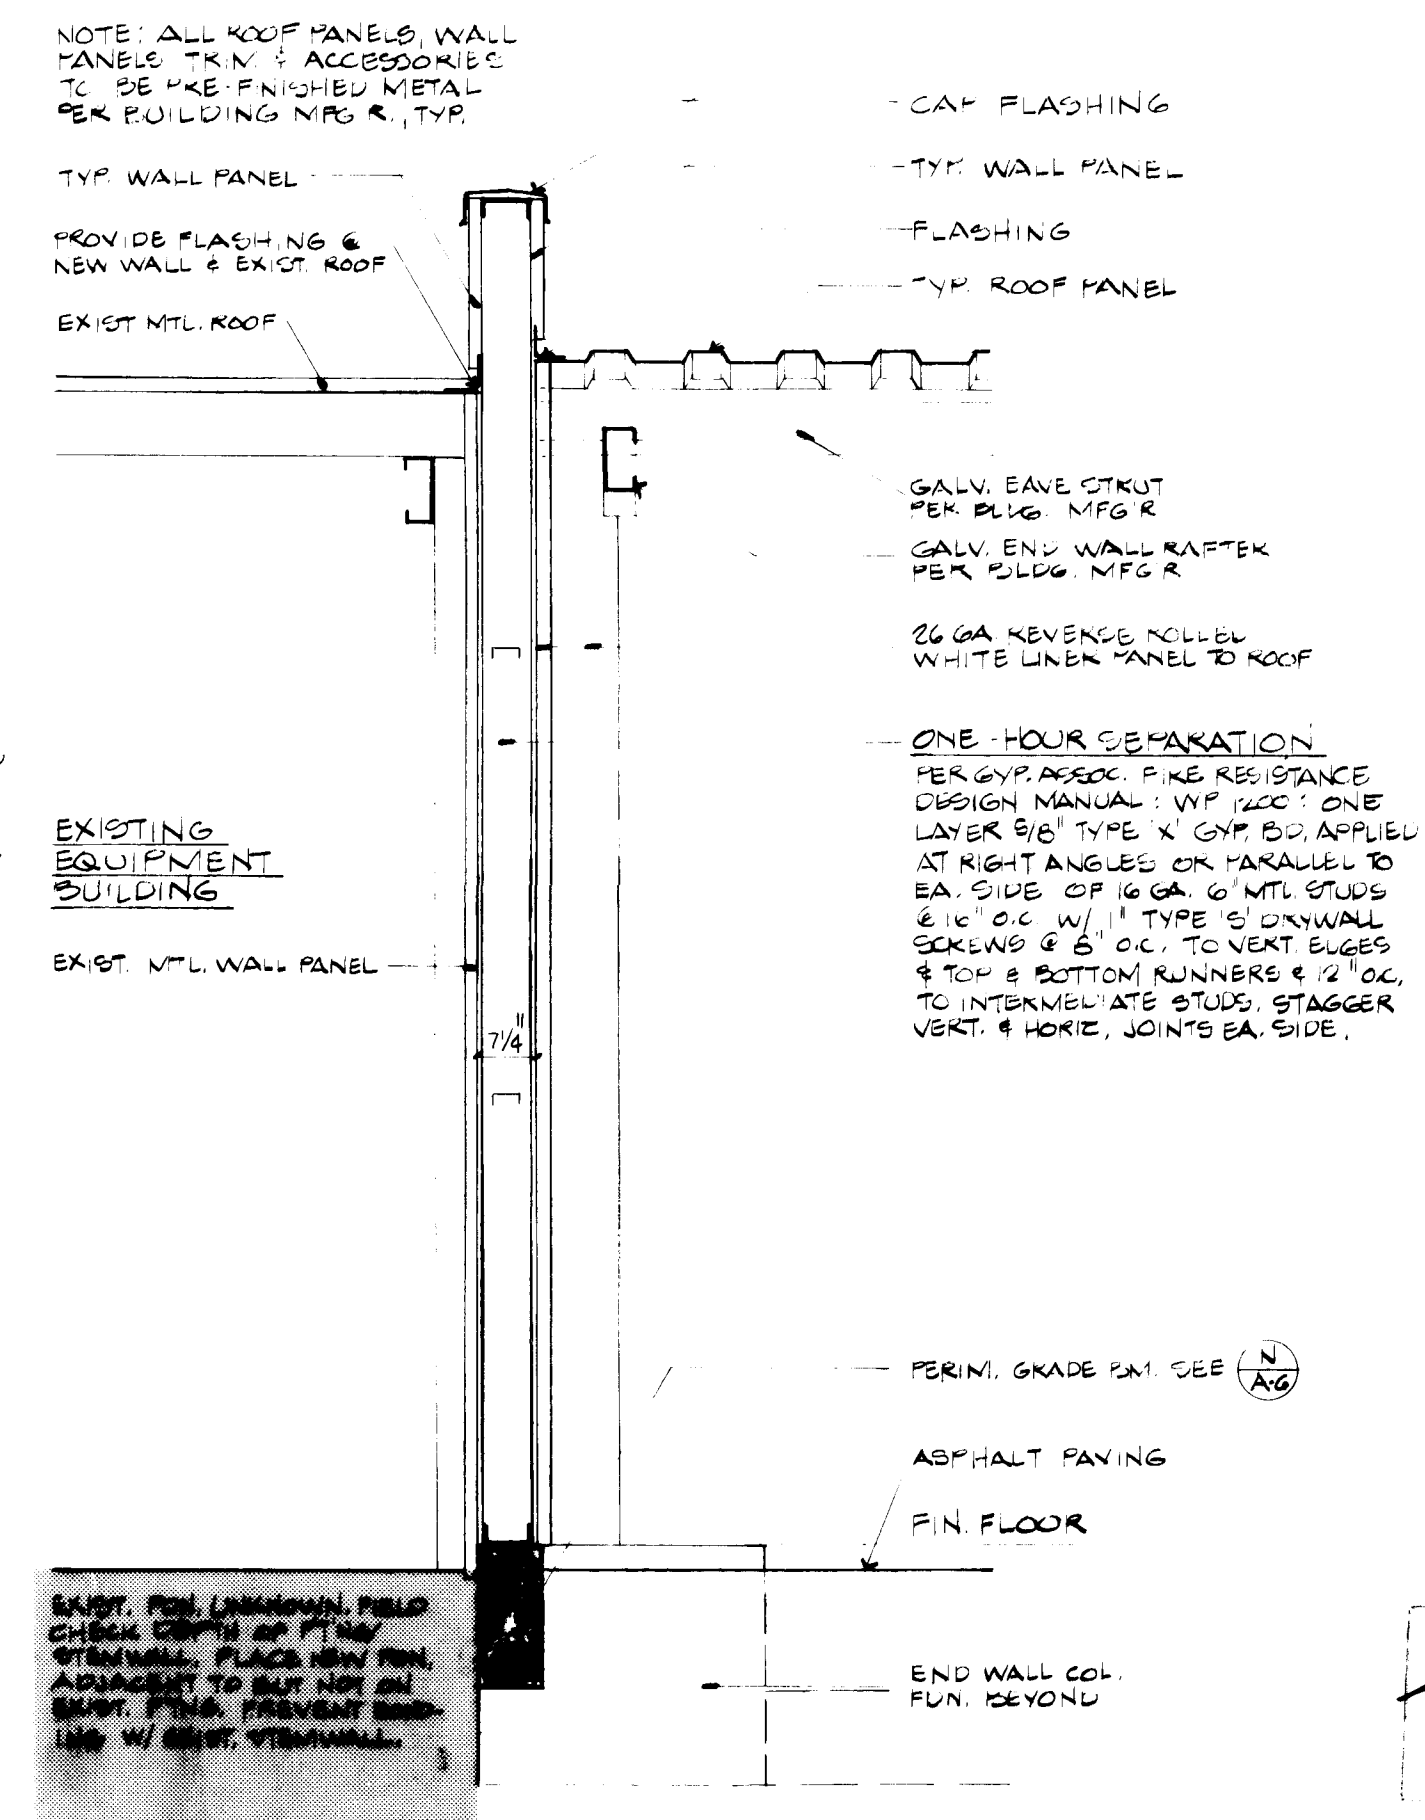

26 28070988







E ONE-HOUR SEPARATION

1/2" = 1'-0"

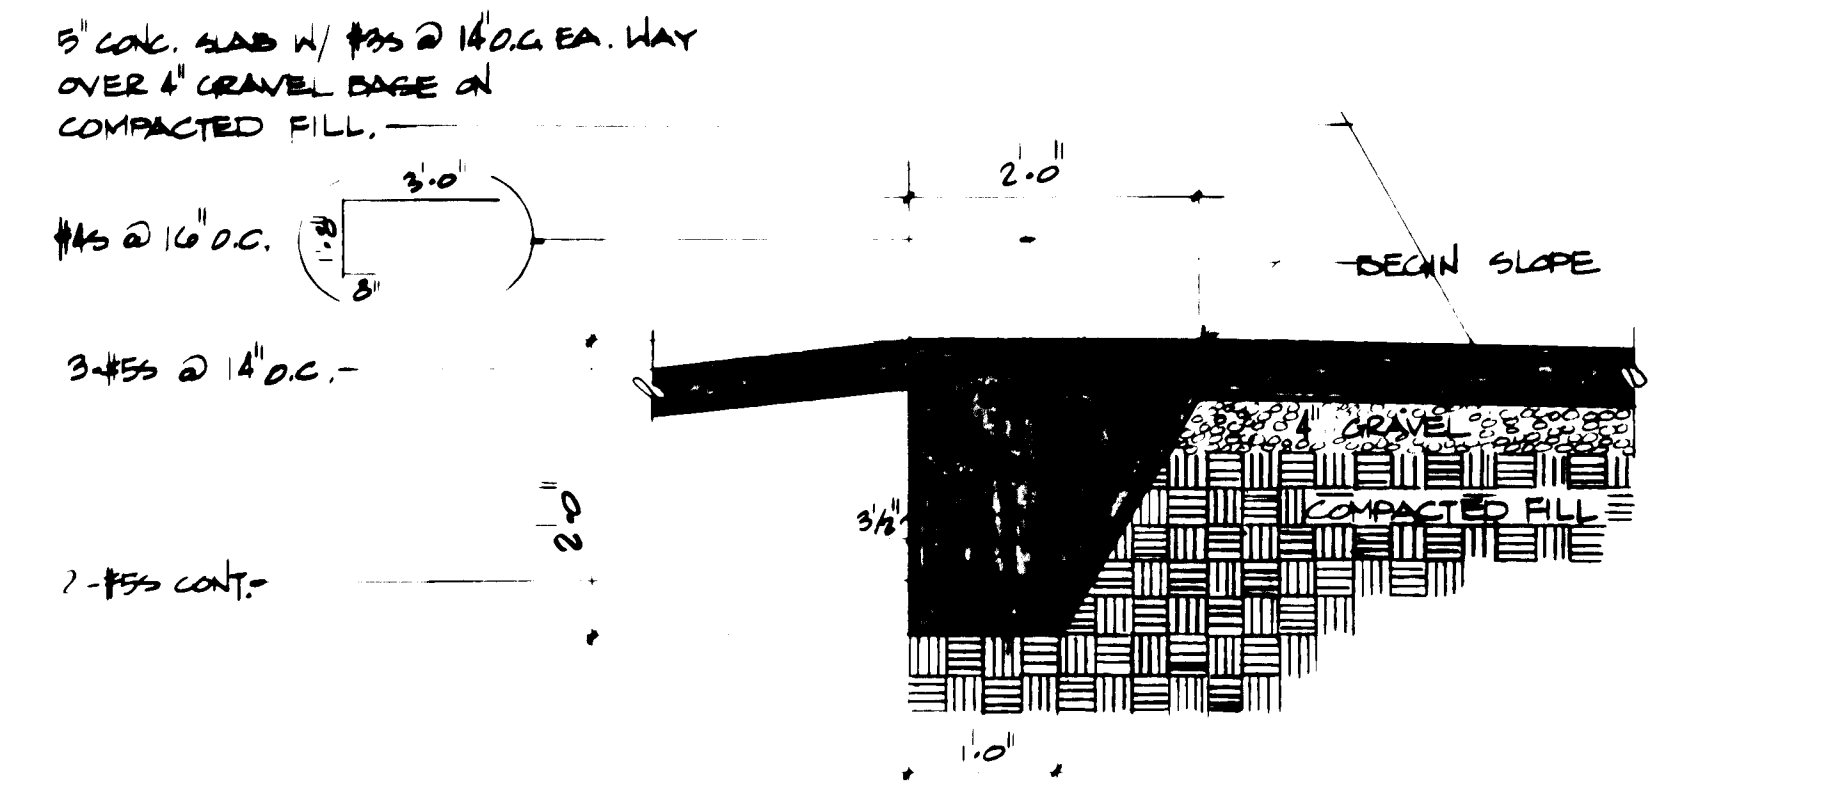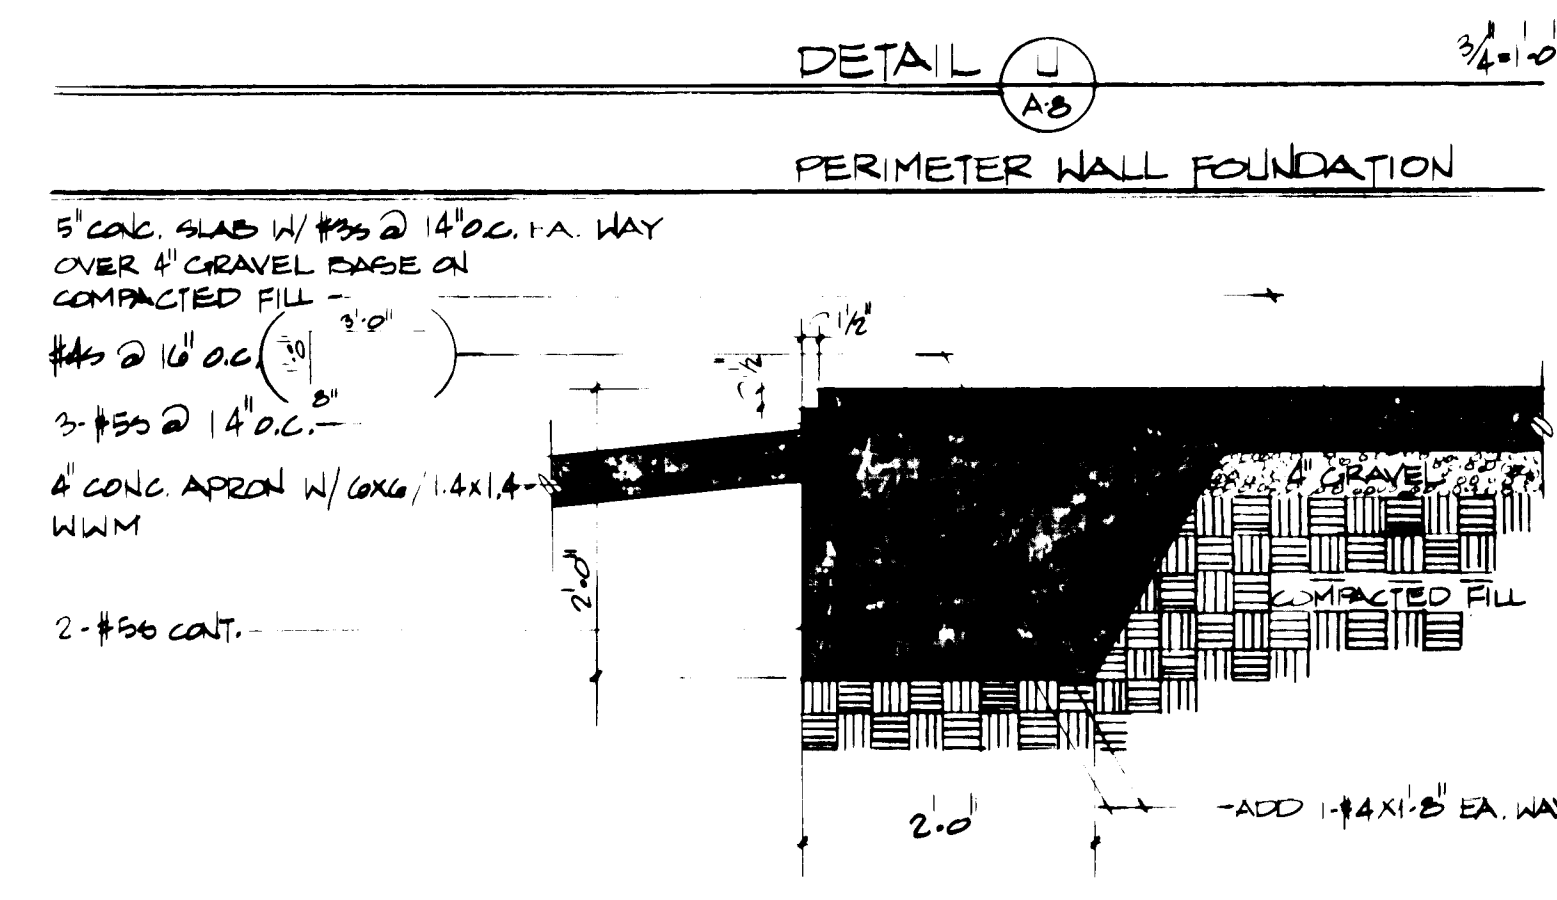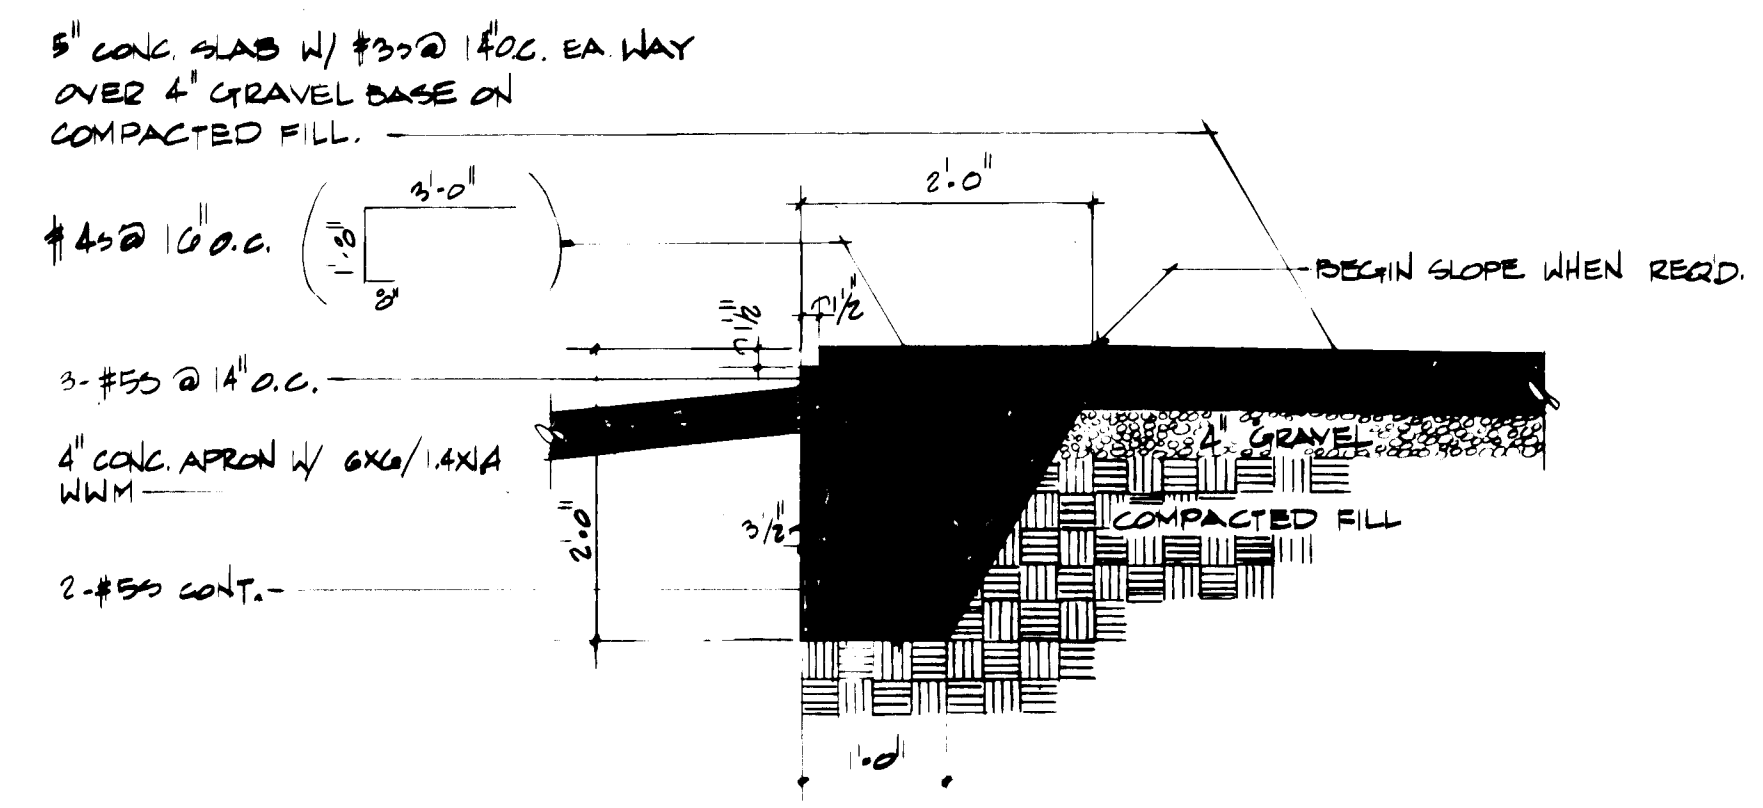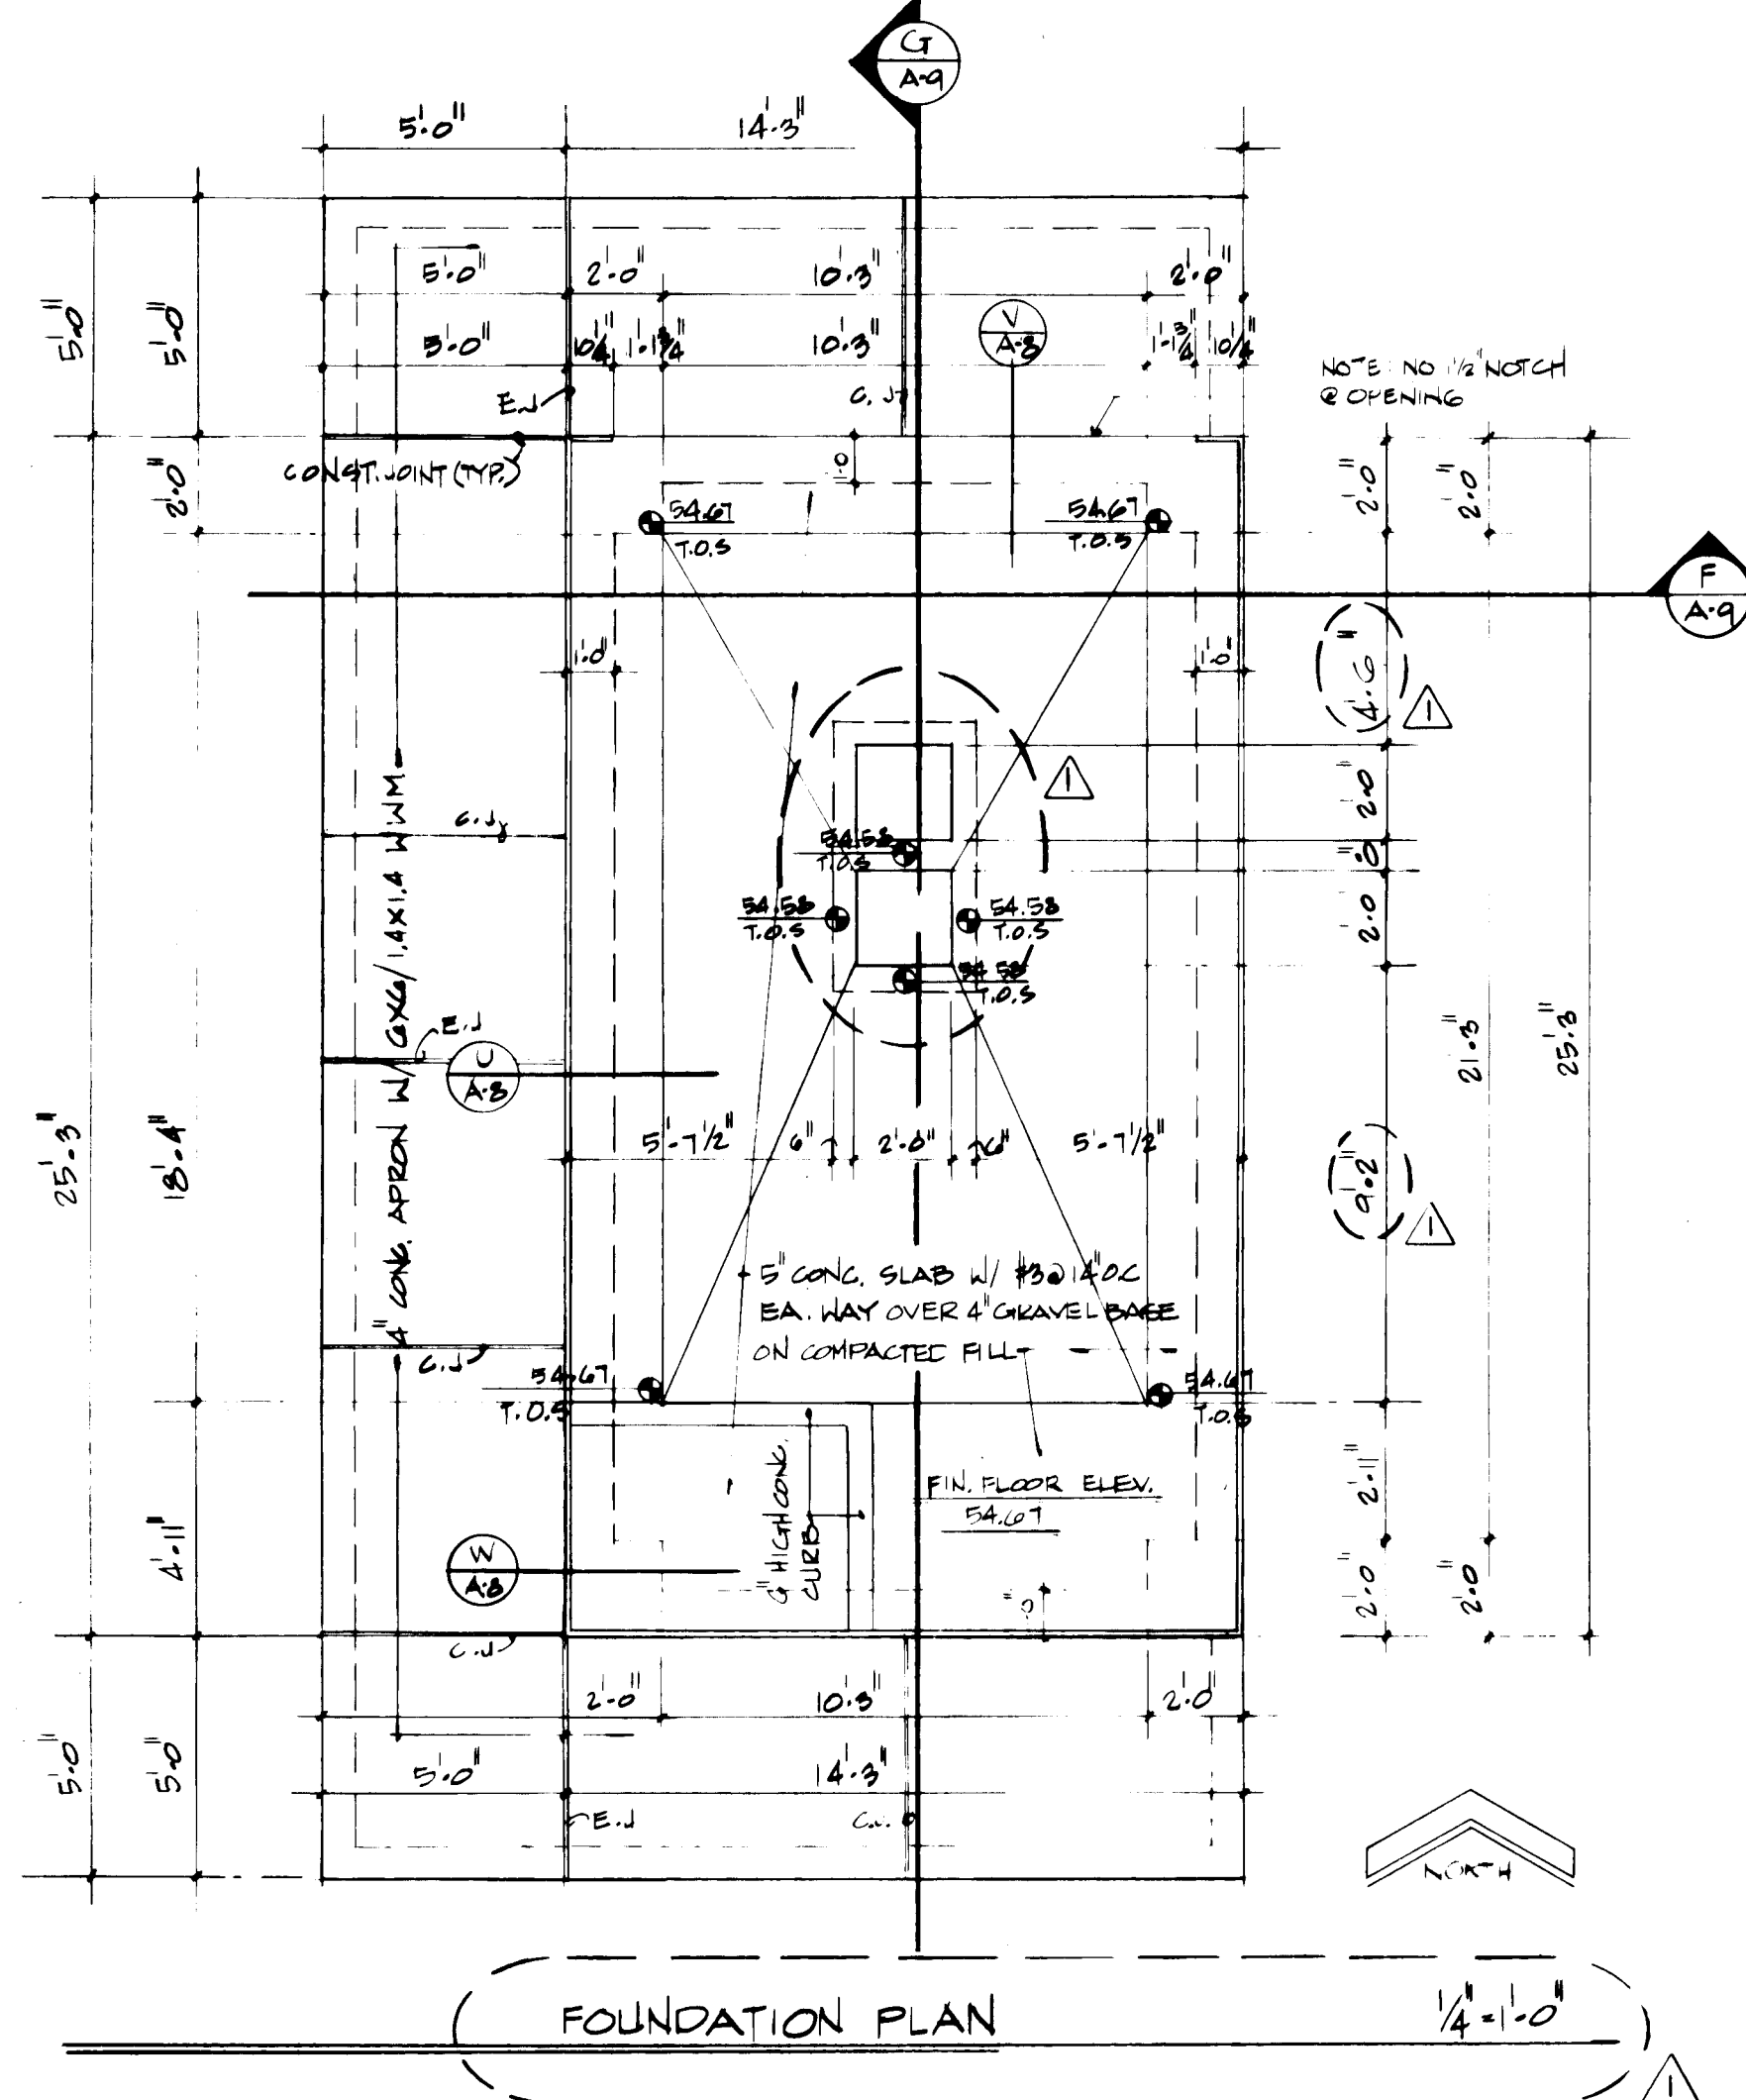

DOOR SCHEDULE




No.	SIZE	TYPE	WARE	FRAME	THRESHOLD	REMARKS
17	2'-0" X 6'-8" X 1/2"	A	T	H.M.	●	INSULATED
18	2'-0" X 7'-0" X 1/2"	A	T	H.M.	●	INSULATED

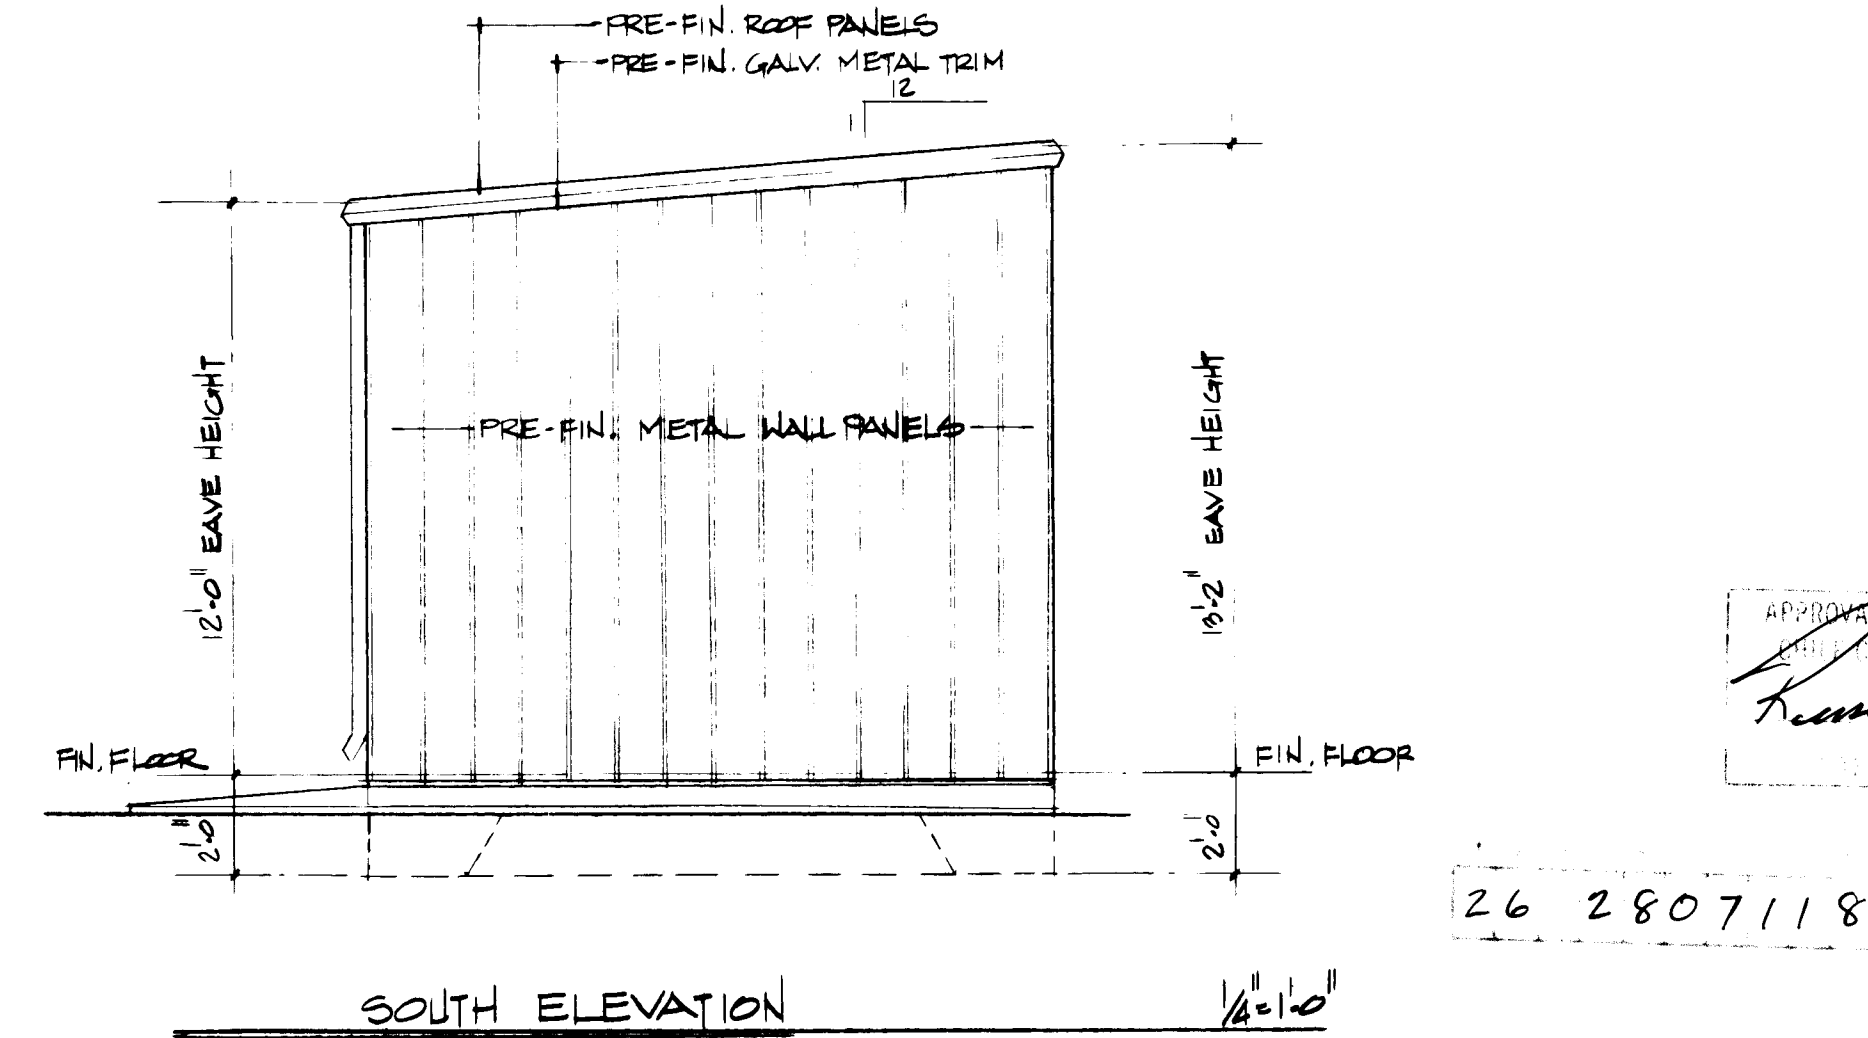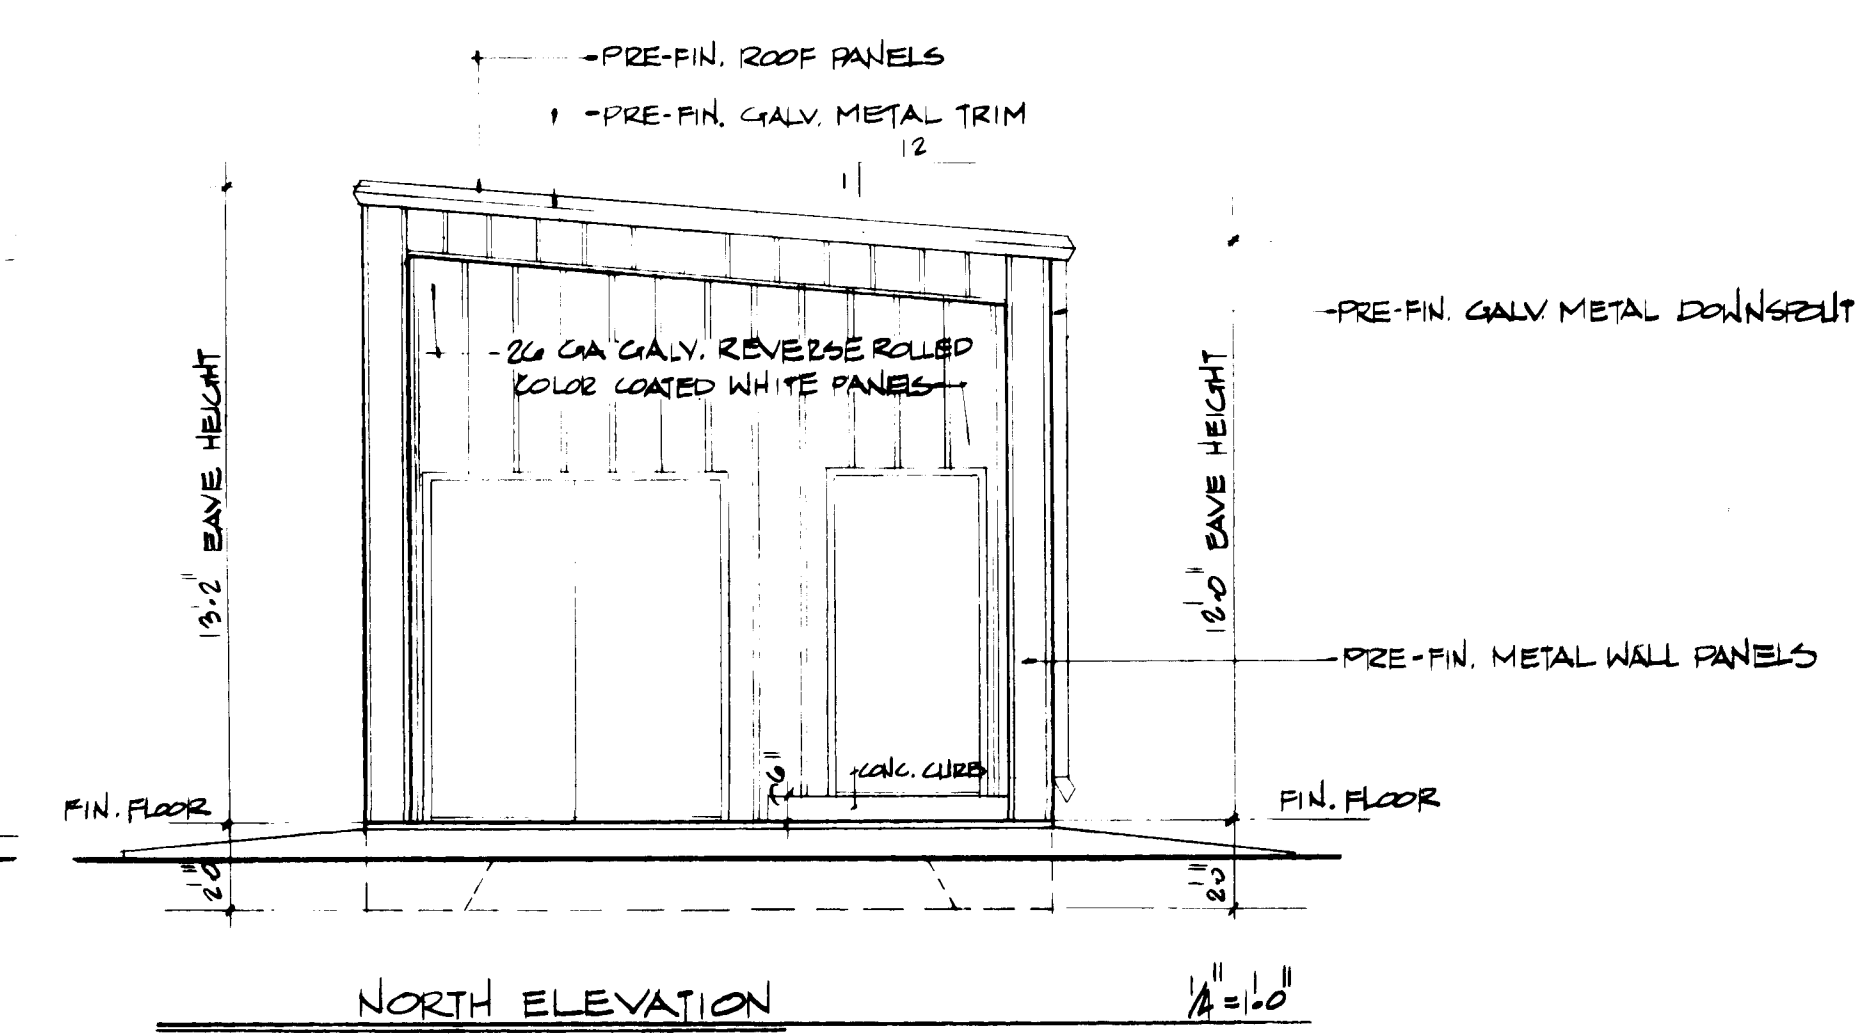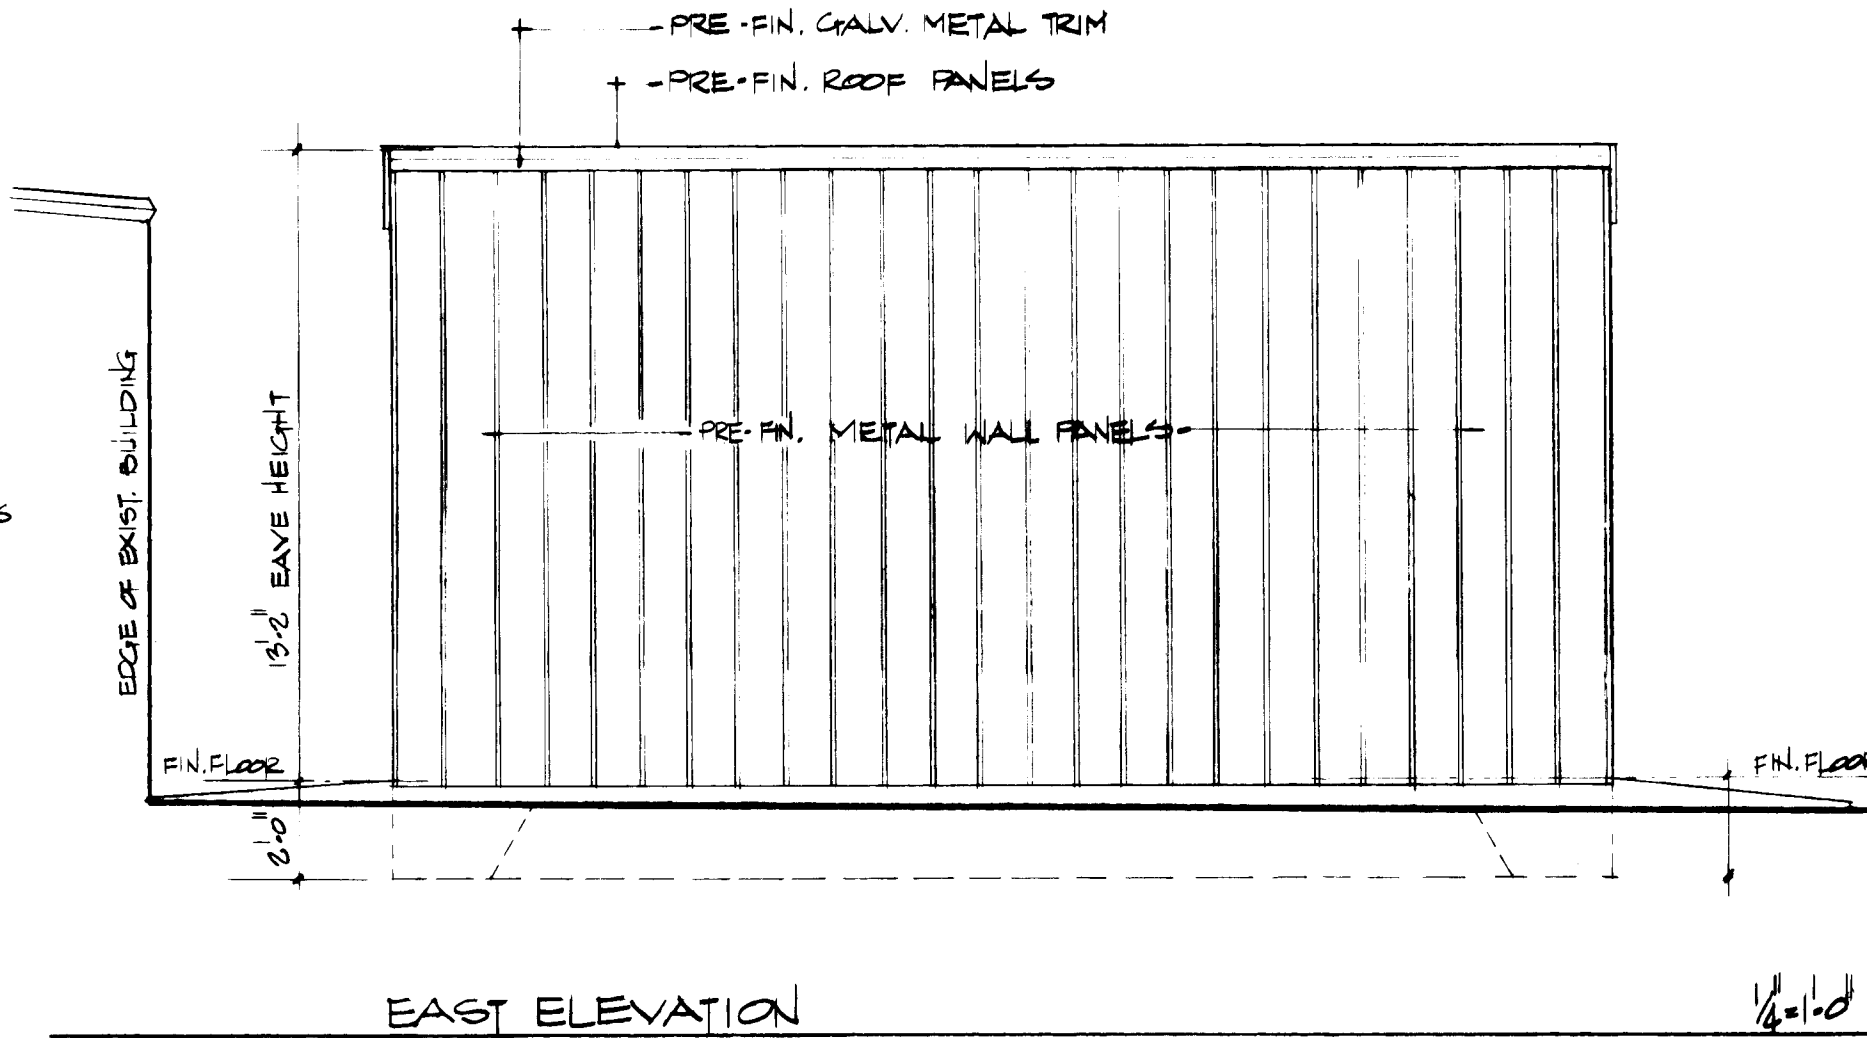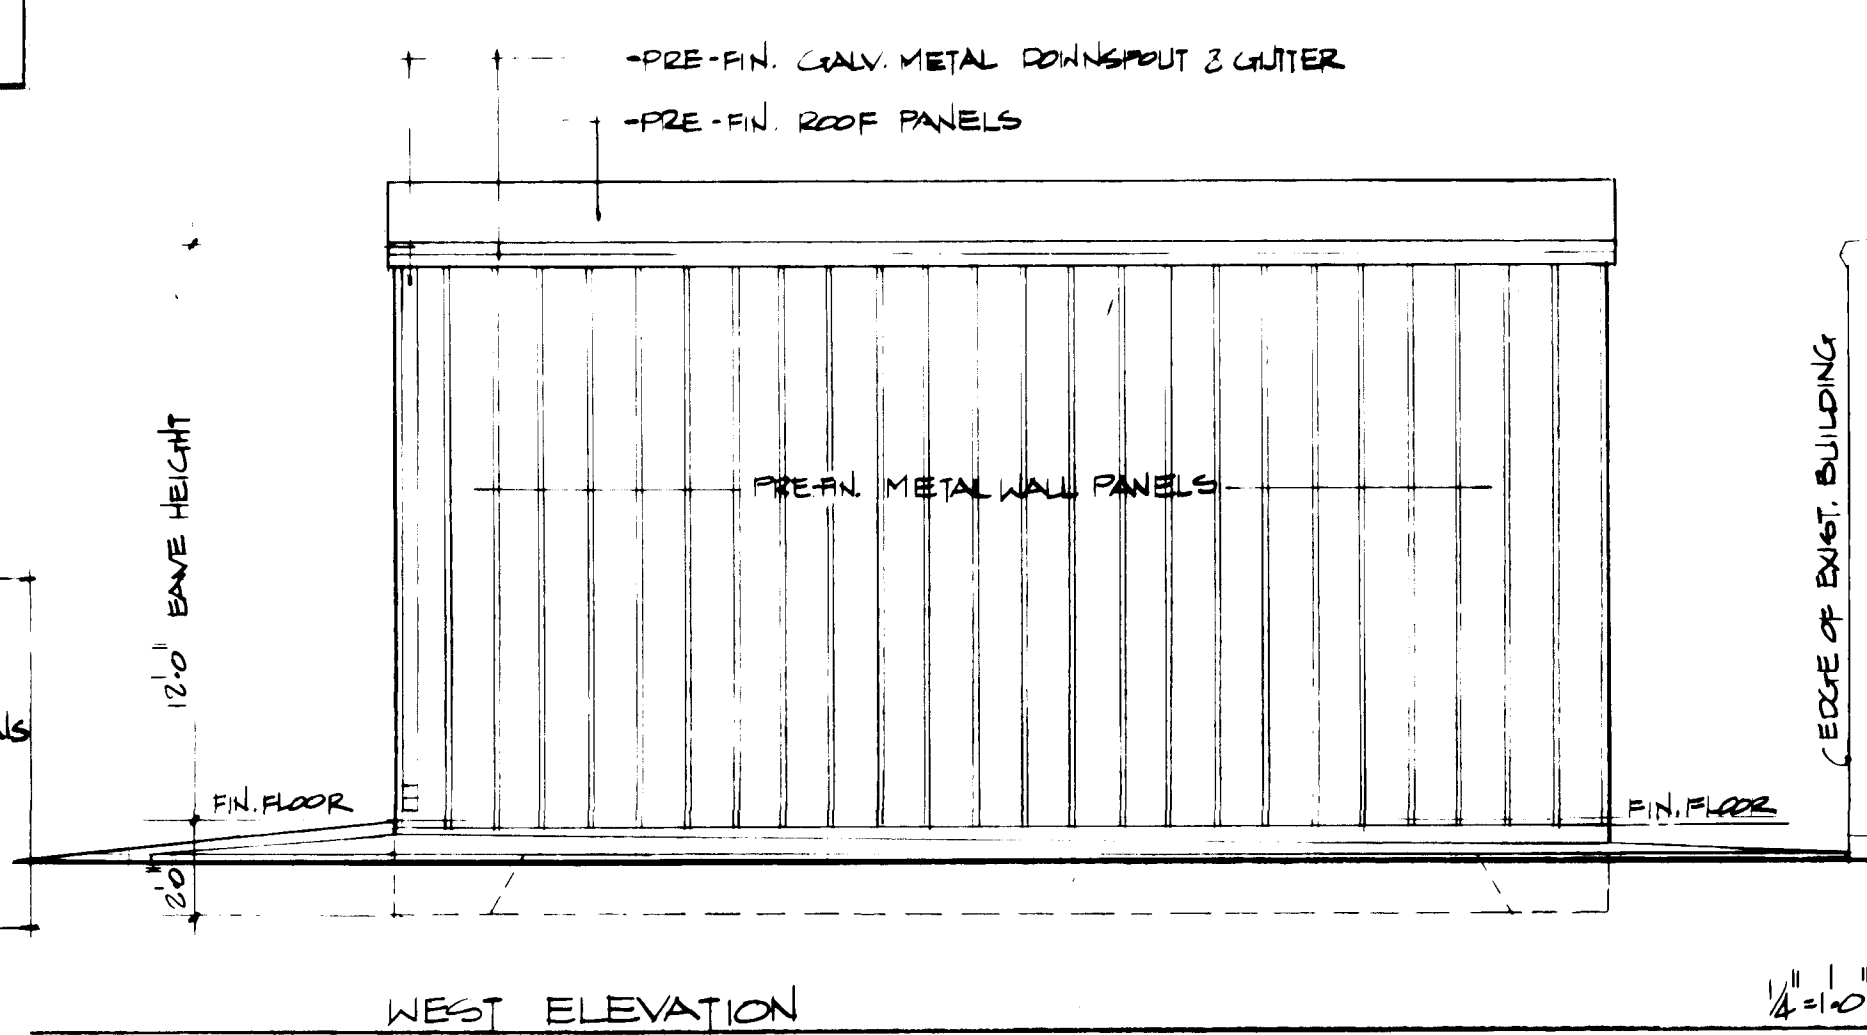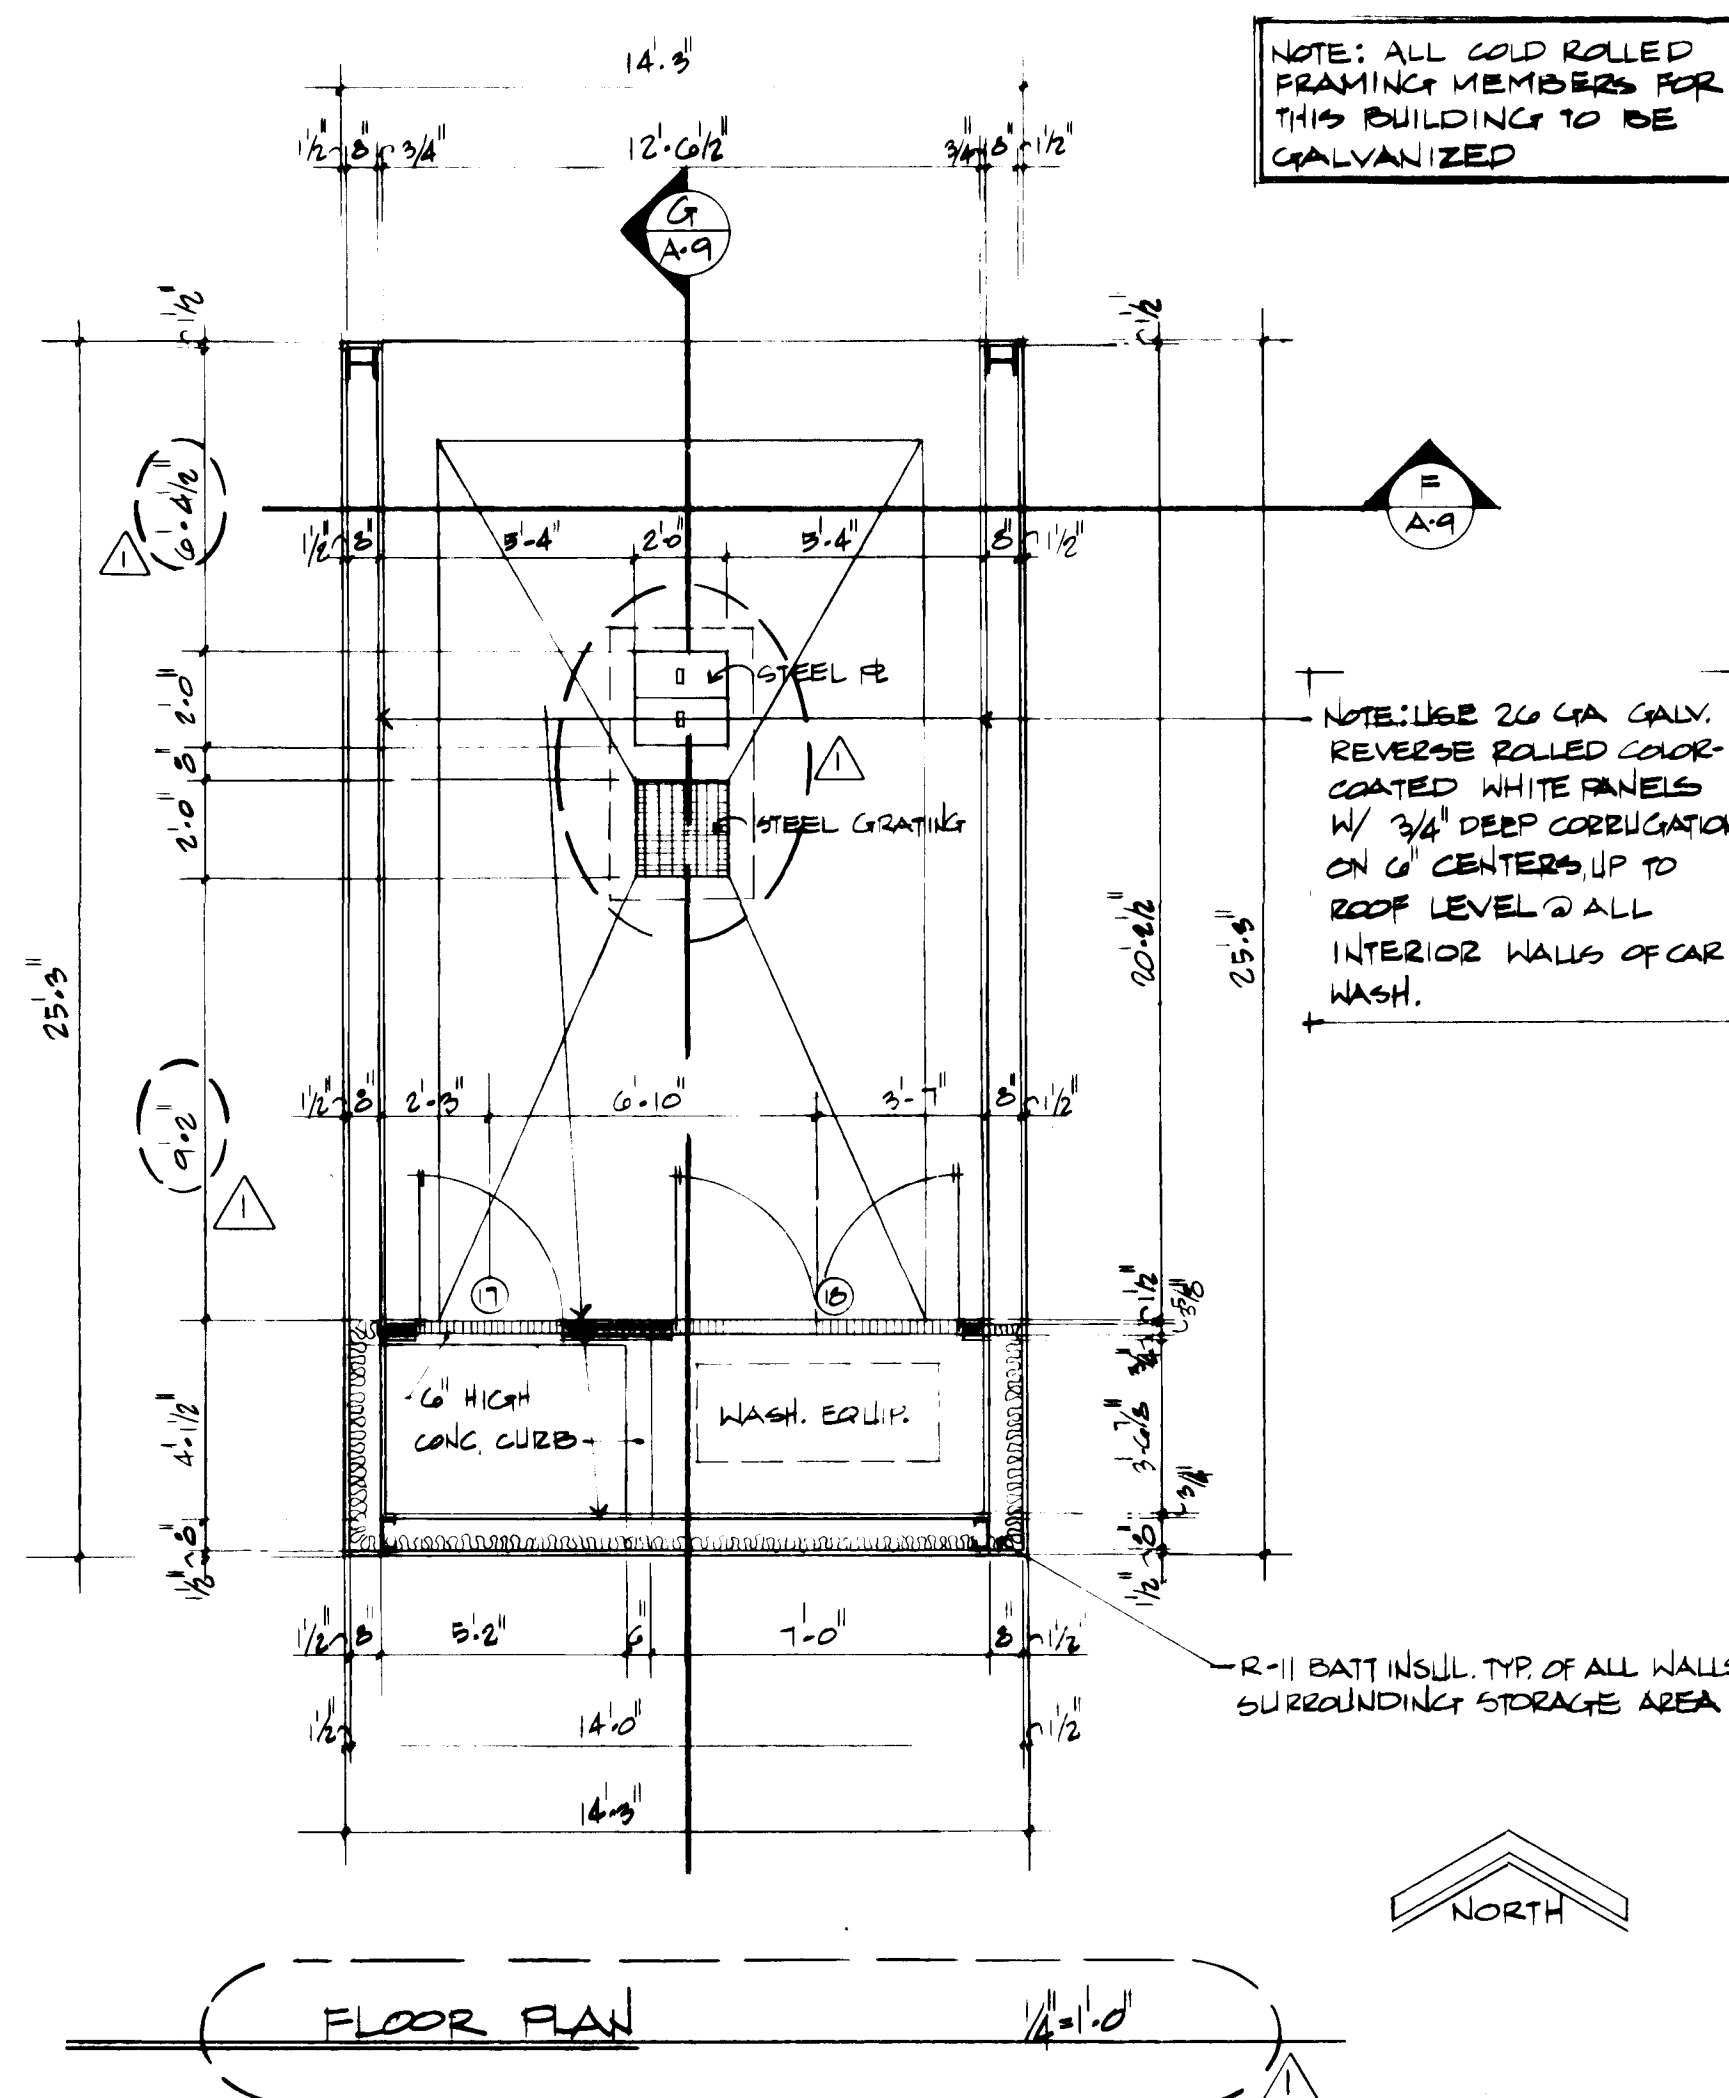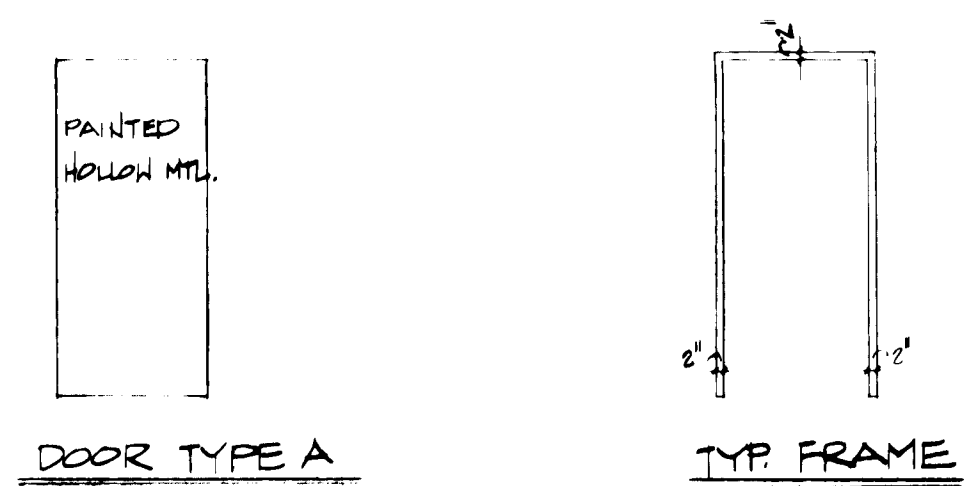

APPROVED BY

 1-12-88

26 28071188

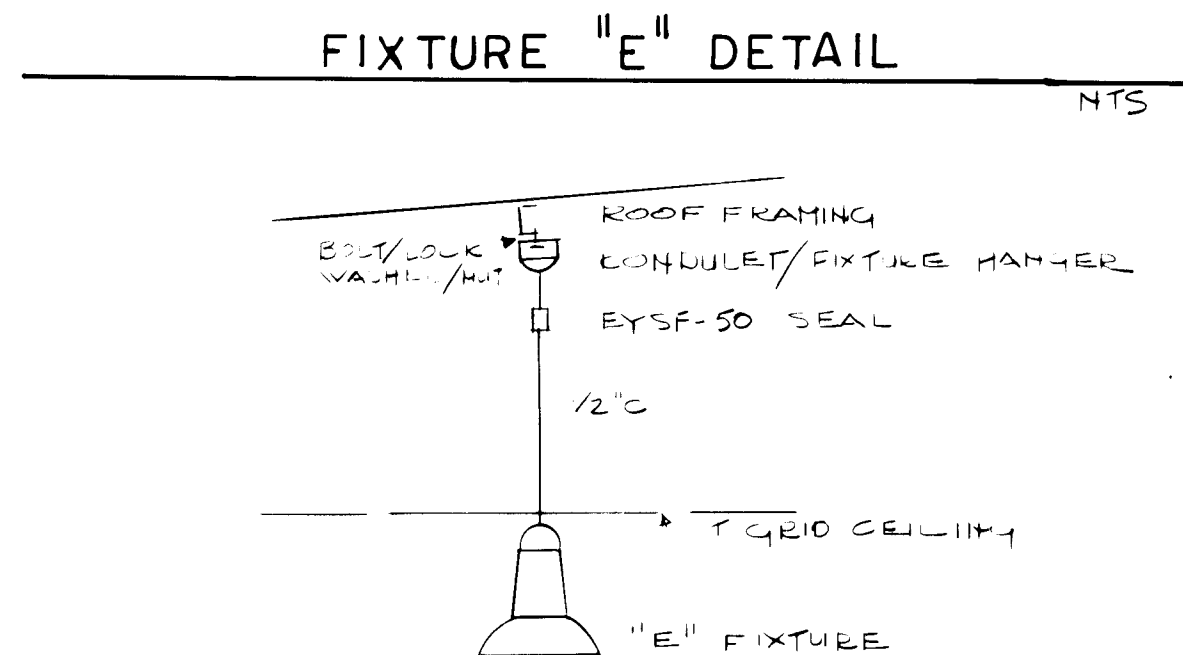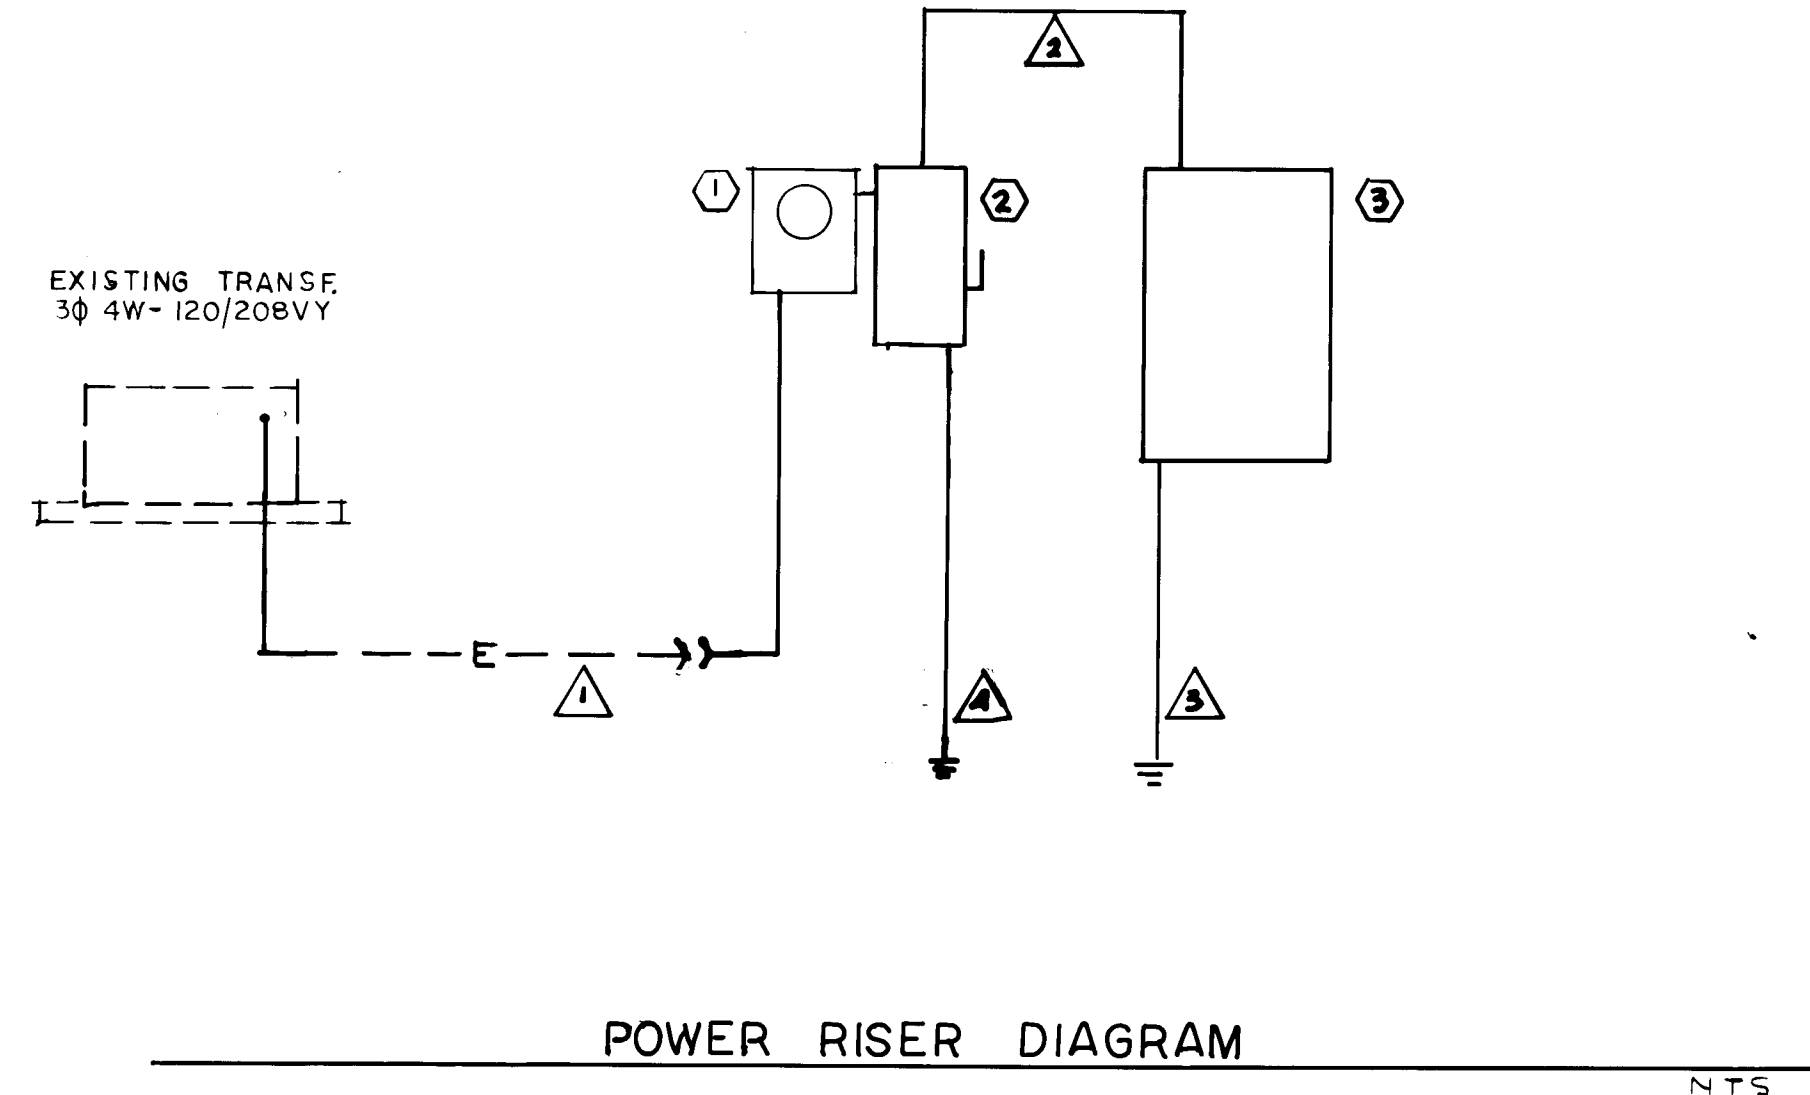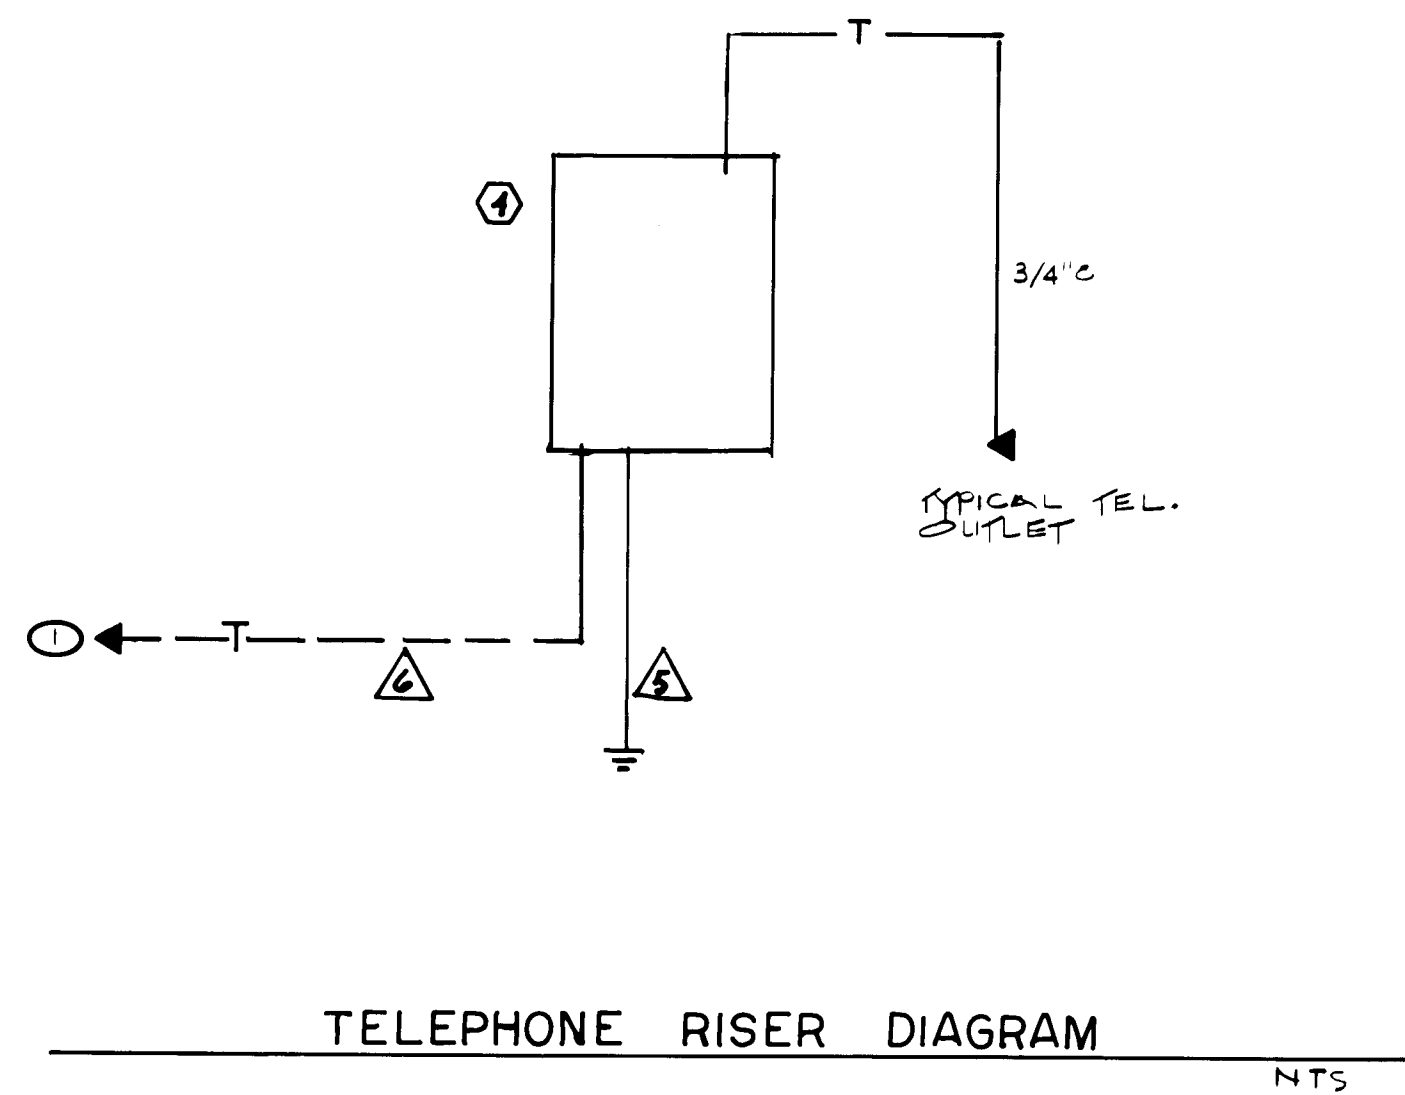

PANEL P SCHEDULE	
1' LTS - OFFICES/SR.	20
3 - H/L/O/SIDE	20
5 - OFF/MOS. LAB	20
7 - PLQ. LAB	20
9 - RBMS/SR	20
11 - COFF/FIICH	20
13 SPACE	20
15 "	20
17 "	20
19 "	20
21 "	20
23 SPACE	20
25 "	20
27 "	20
29 "	20
31 "	20
33 "	20
35 "	20
37 "	20
39 "	20

- ### ELECTRICAL EQUIPMENT
- ELECTRIC METER, 3#, 200A, PER P.A.M. DWG. 75-19-11.4
 - MAIN DISCONNECT SWITCH, 4W, 5/N, 240V, 100A, NEMA-3R, HEAVY DUTY TYPE, FUSED. USE TYPE "FRN-100" FUSES.
INSTALL SJ-D, TYPE #J9200-9A, SURGE PROTECTOR INTO DISCONNECT ON PANEL P.
 - PANEL P
3#4W, 120-208VY, 200A BUS, M.L.D., FLUSH MTD. SJ-D, TYPE "QQ" WITH 10,000AIC BREAKERS. SEE PANEL SCHEDULE.
 - TELEPHONE TERMINAL BOARD, 3'x4'x3/4" PLYWOOD.
4 #1-THW-LU-2"U.
4 #1-THW-LU-2"U.
1 #4-LU TO C.W.P.
1 #1-LU-1"U. TO GND, RND 5/8"x3/4" CU-CLAD
1 #1-LU TO C.W.P.

ELECTRICAL DATA

1. ESTIMATED NEW CONNECTED LOAD:	21 KW
ESTIMATED NEW DEMAND LOAD:	10 KW

- ### KEYED NOTES
- 1" C, OUT TO AND UP UTILITY POLE. VERIFY EXACT LOCATION.
 - APPLETON TYPE #EHR-56/EHRA-56 RECESSED FLUSH IN WALL TYPICAL OF ALL. CONTRACTOR TO FURNISH 3 EACH, APPLETON #EHR-56 PLUGS.
 - APPLETON #EFS-175-F1, 1P SWITCH FLUSH IN WALL.
 - PLAGUE LAB AREA WIRED PER N.E.C. ART. 501 FOR CLASS I DIVISION II.
 - INTERLOCK EXHAUST FAN WITH FURNACE. PROVIDE RELAY AS REQUIRED.
 - AT THIS LOCATION INSTALL ONE EACH TIMER, FLUORESCENT DIMMER AND 1P SWITCH:
1 -TORX #72002-L-FL1
1 -LUTRON #FD-12 (FLUOR. DIMMER)
1 -1P SW
 - INSTALL DIMMING FLUORESCENT BALLAST IN FIXTURE TYPE "C". (ADVANCE #240-H OR EQUAL)
 - APPLETON #EHR-3023/CPP-3023C

SYMBOLS









SWITCH, 1P, 20A SPEC. GRADE	UP 52"
SWITCH, 2P, 20A SPEC. GRADE	UP 52"
SWITCH, EXPLOSION PROOF	UP 52"
SWITCH, 3W, 20A, SPEC. GRADE	UP 52"
DUPLEX OUTLET, 15A, SPEC. GRADE	UP 18"
OUTLET, EXPLOSION PROOF	UP 18"
JUNCTION BOX	
EXIT LIGHT	
EMERGENCY LIGHT	
LIGHT FIXTURE, CEILING SURFACE MTD.	
LIGHT FIXTURE, WALL MTD.	
LIGHT FIXTURE, RECESSED IN CEILING	
LIGHT FIXTURE, FLUSH IN CLG. GRID	
DISCONNECT SWITCH, FUSED	
MOTOR STARTER/CONTACTOR	
CIRCUIT BREAKER PANEL	
TELEPHONE TERMINAL BOARD	
TELEPHONE OUTLET	UP 18"
PHOTO CELL	
CONDUIT AND WIRE IN WALL AND CEILING	
CONDUIT AND WIRE UNDERGROUND	
CONDUIT AND WIRE HOME RUN TO PANEL	
ELECTRICAL CONDUIT	
TELEPHONE CONDUIT	
DUPLEX OUTLET FLUSH IN CEILING	

- ### ELECTRICAL NOTES
- CONTRACTOR SHALL VERIFY THE EXACT LOCATIONS AND TYPE OF EQUIPMENT, CONNECTIONS AND CONTROLS REQUIRED FOR ALL MECHANICAL AND PLUMBING EQUIPMENT. THEN PROVIDE ALL LABOR, MATERIALS AND CONTROLS TO MAKE A COMPLETE AND OPERATIONAL SYSTEM. PROVIDE ALL TESTING AS MAY BE REQUIRED.
 - CONTRACTOR IS REQUIRED TO INSTALL, CONNECT, FURNISH MATERIALS AND MAKE OPERATIONAL THOSE ITEMS NOT SHOWN OR IMPLIED ON THE CONSTRUCTION DRAWINGS, BUT ARE REQUIRED UNDER OTHER SECTIONS OF THE SPECIFICATIONS AND DRAWINGS.
 - DO NOT SCALE DRAWINGS FOR EXACT LOCATIONS. USE ONLY THE ARCHITECTURAL DIMENSIONS.
 - ALL MOTORS AND MECHANICAL EQUIPMENT SHALL BE CONNECTED WITH FLEX CONDUIT. USE WEATHERPROOF FLEX IN WET OR DAMP LOCATIONS.
 - ANY DISCREPANCIES NOTED ON THE DRAWINGS OR IN THE SPECIFICATIONS SHALL BE BROUGHT TO THE ATTENTION OF THE ARCHITECT, FOR RESOLUTION PRIOR TO INSTALLATION OF THAT SPECIFIED EQUIPMENT.
 - THE ELECTRICAL LAYOUT IS DIAGNOSTIC ONLY. THE CONTRACTOR MAY VARY THE BRANCH CIRCUIT WIRING AS NECESSARY TO MEET ACTUAL FIELD CONSTRUCTION REQUIREMENTS.

Ronald B. Schuster
1-12-58

26 28071888


John P. [Signature]

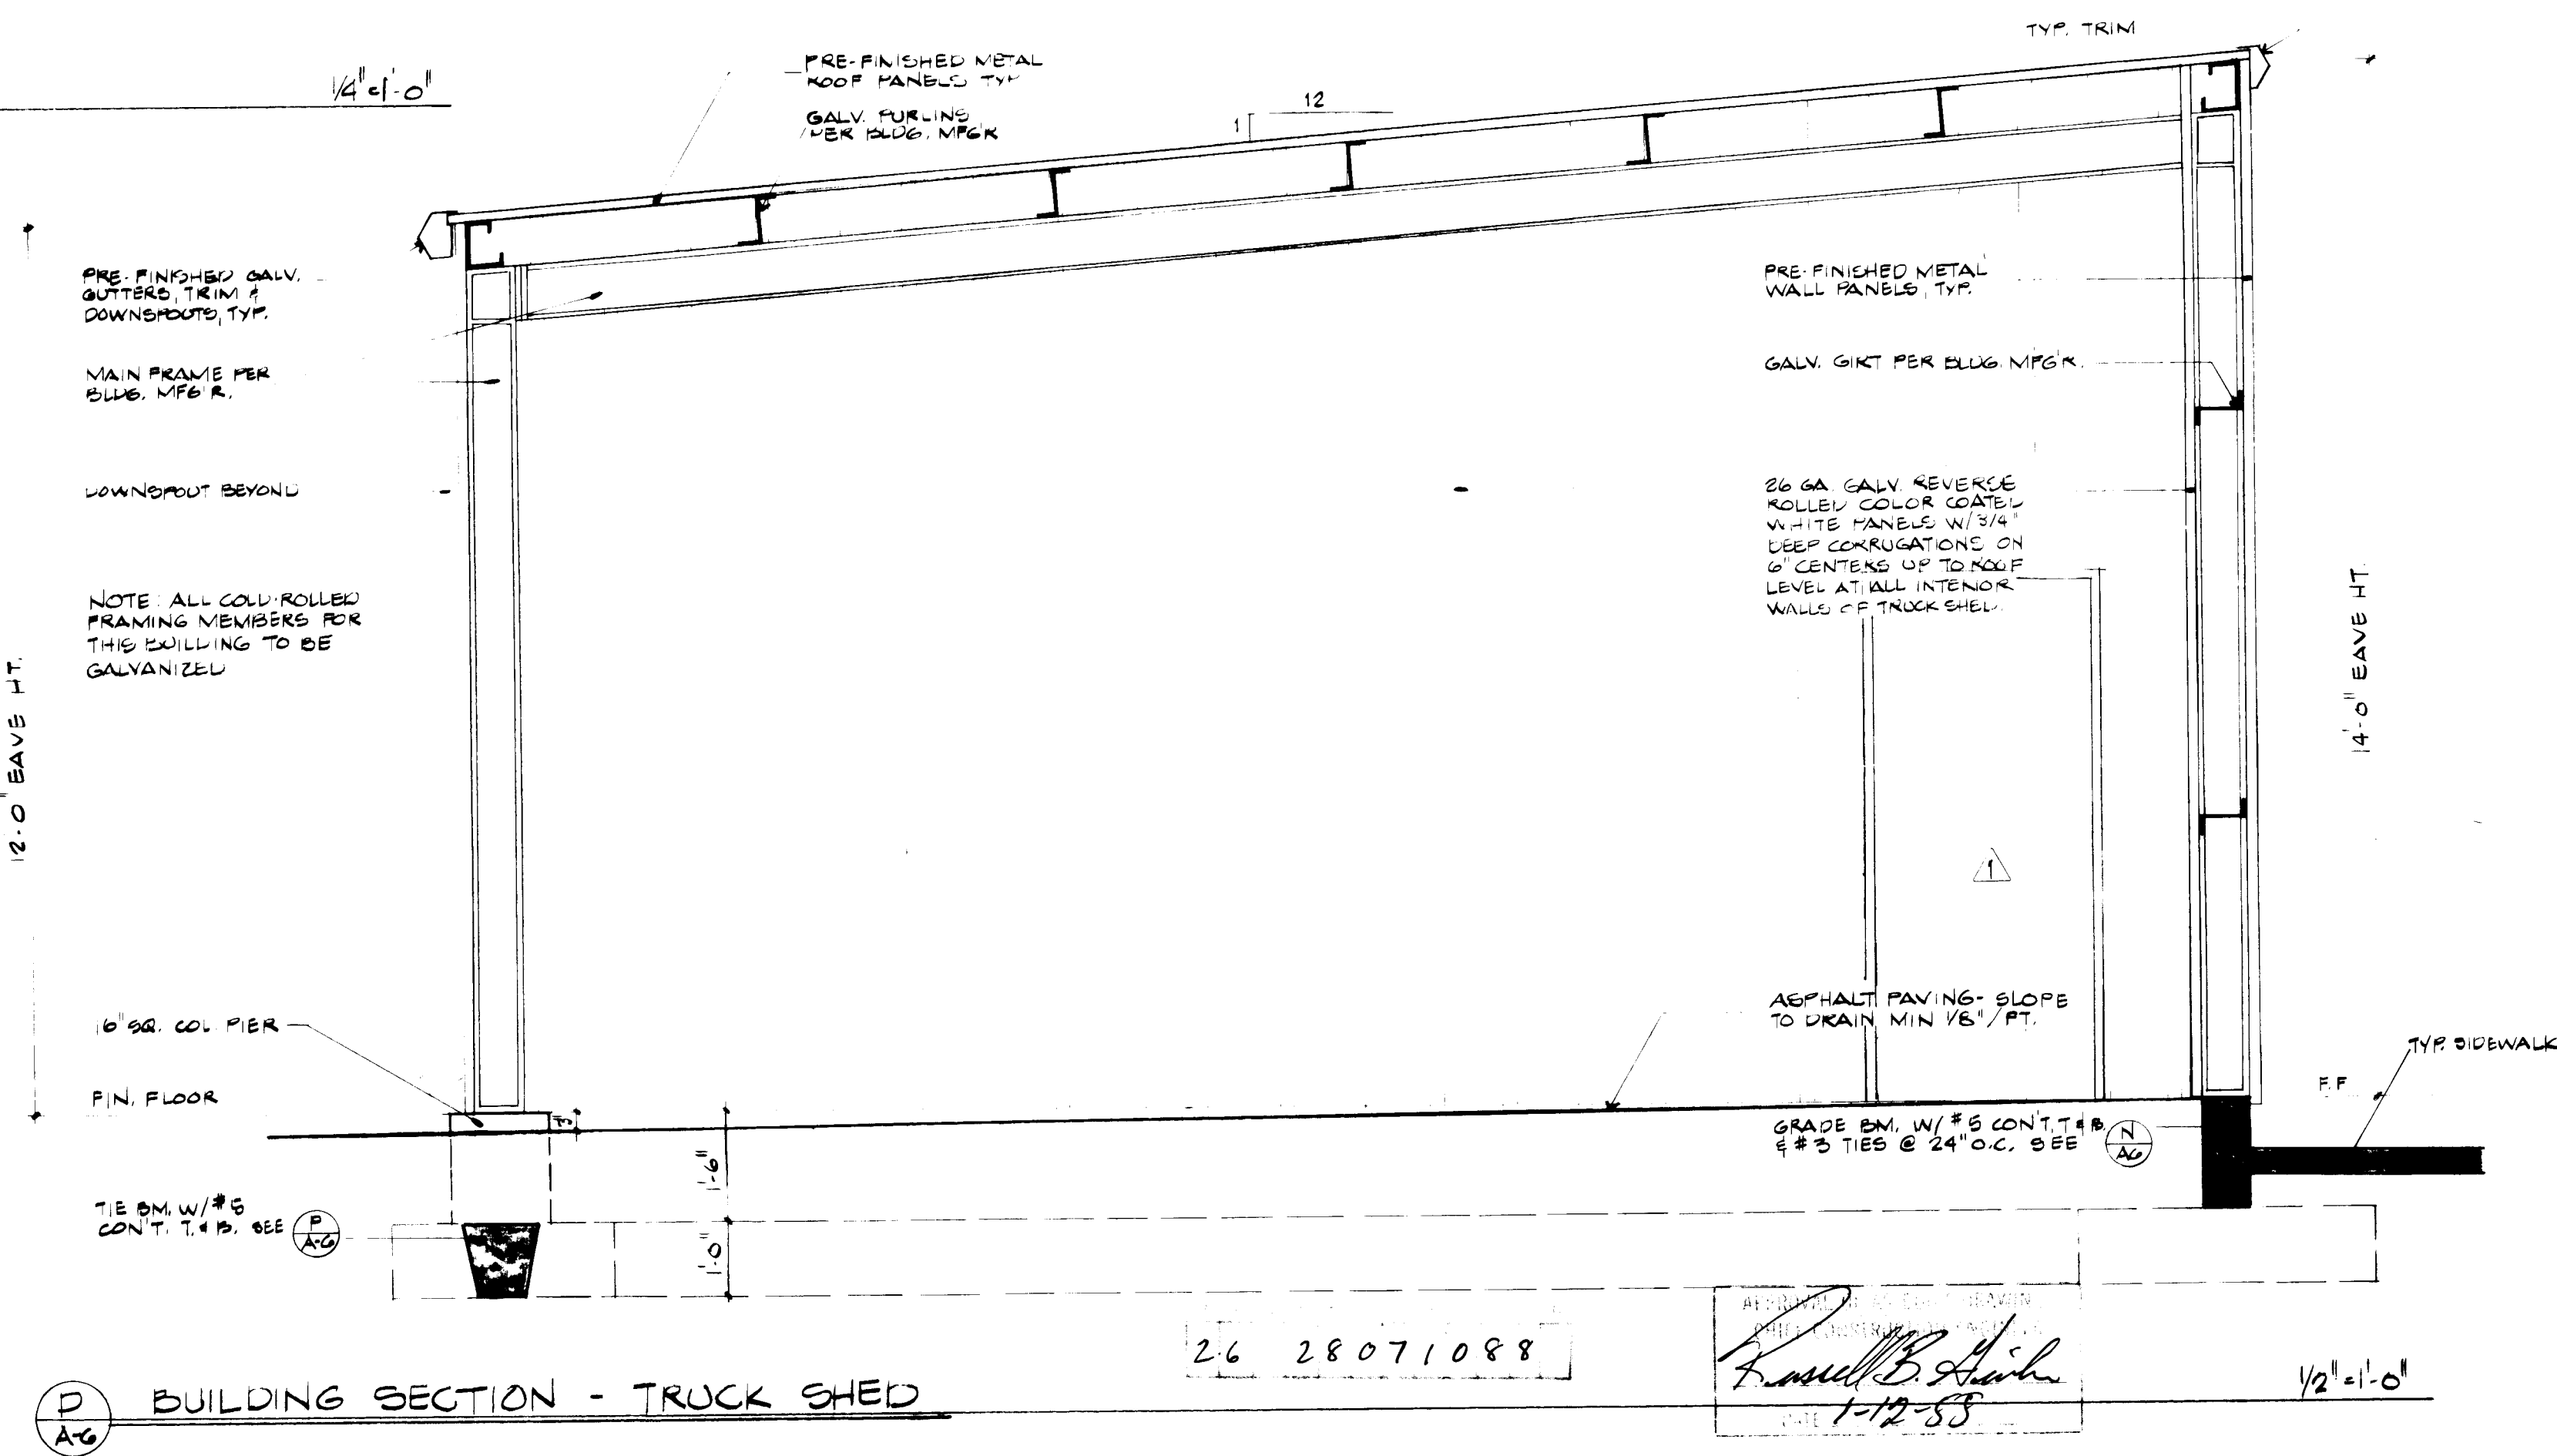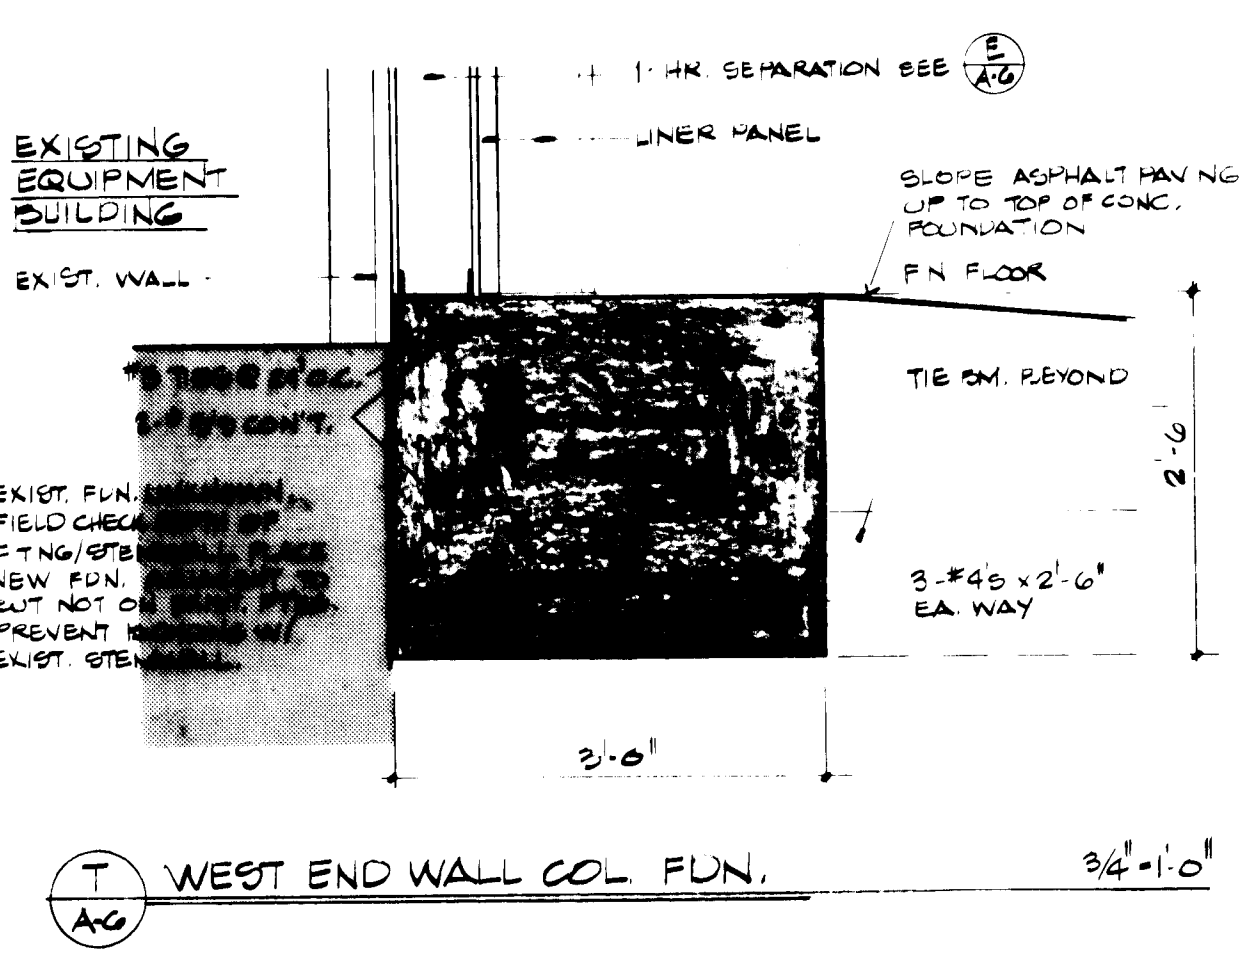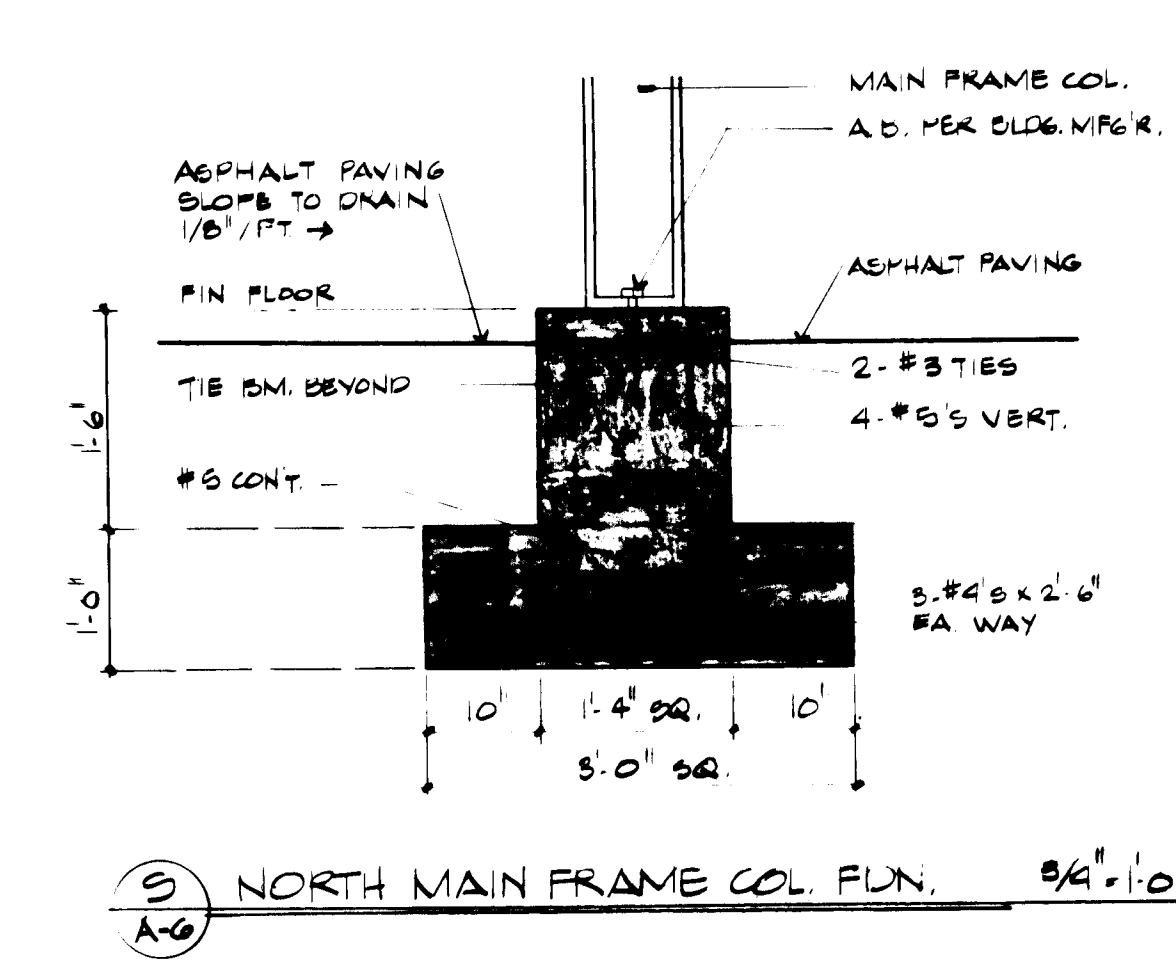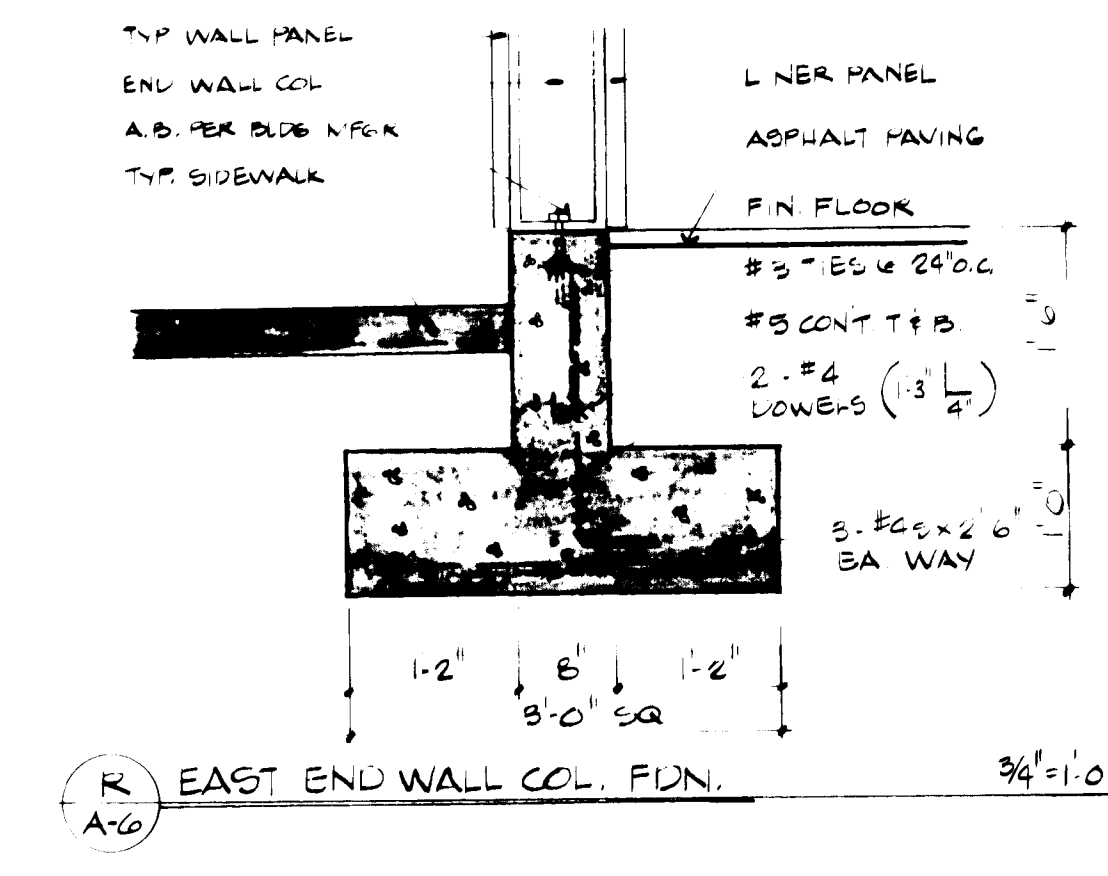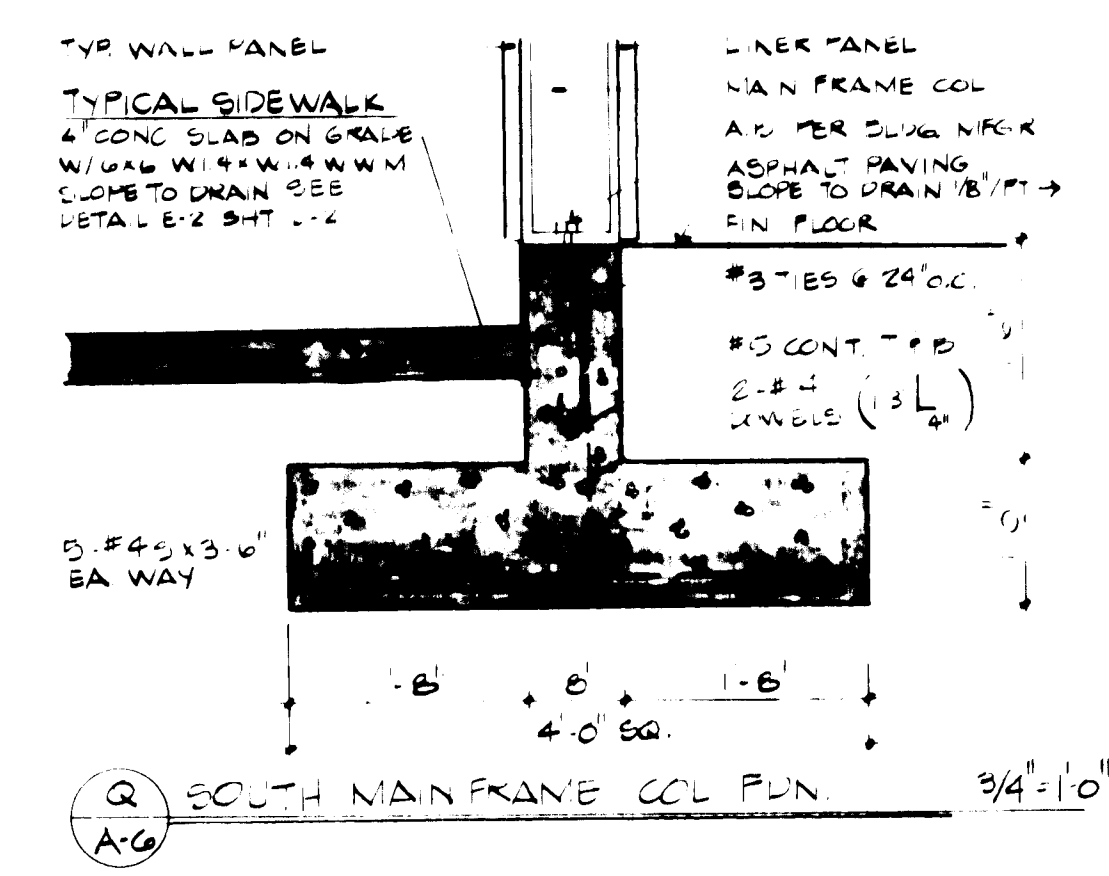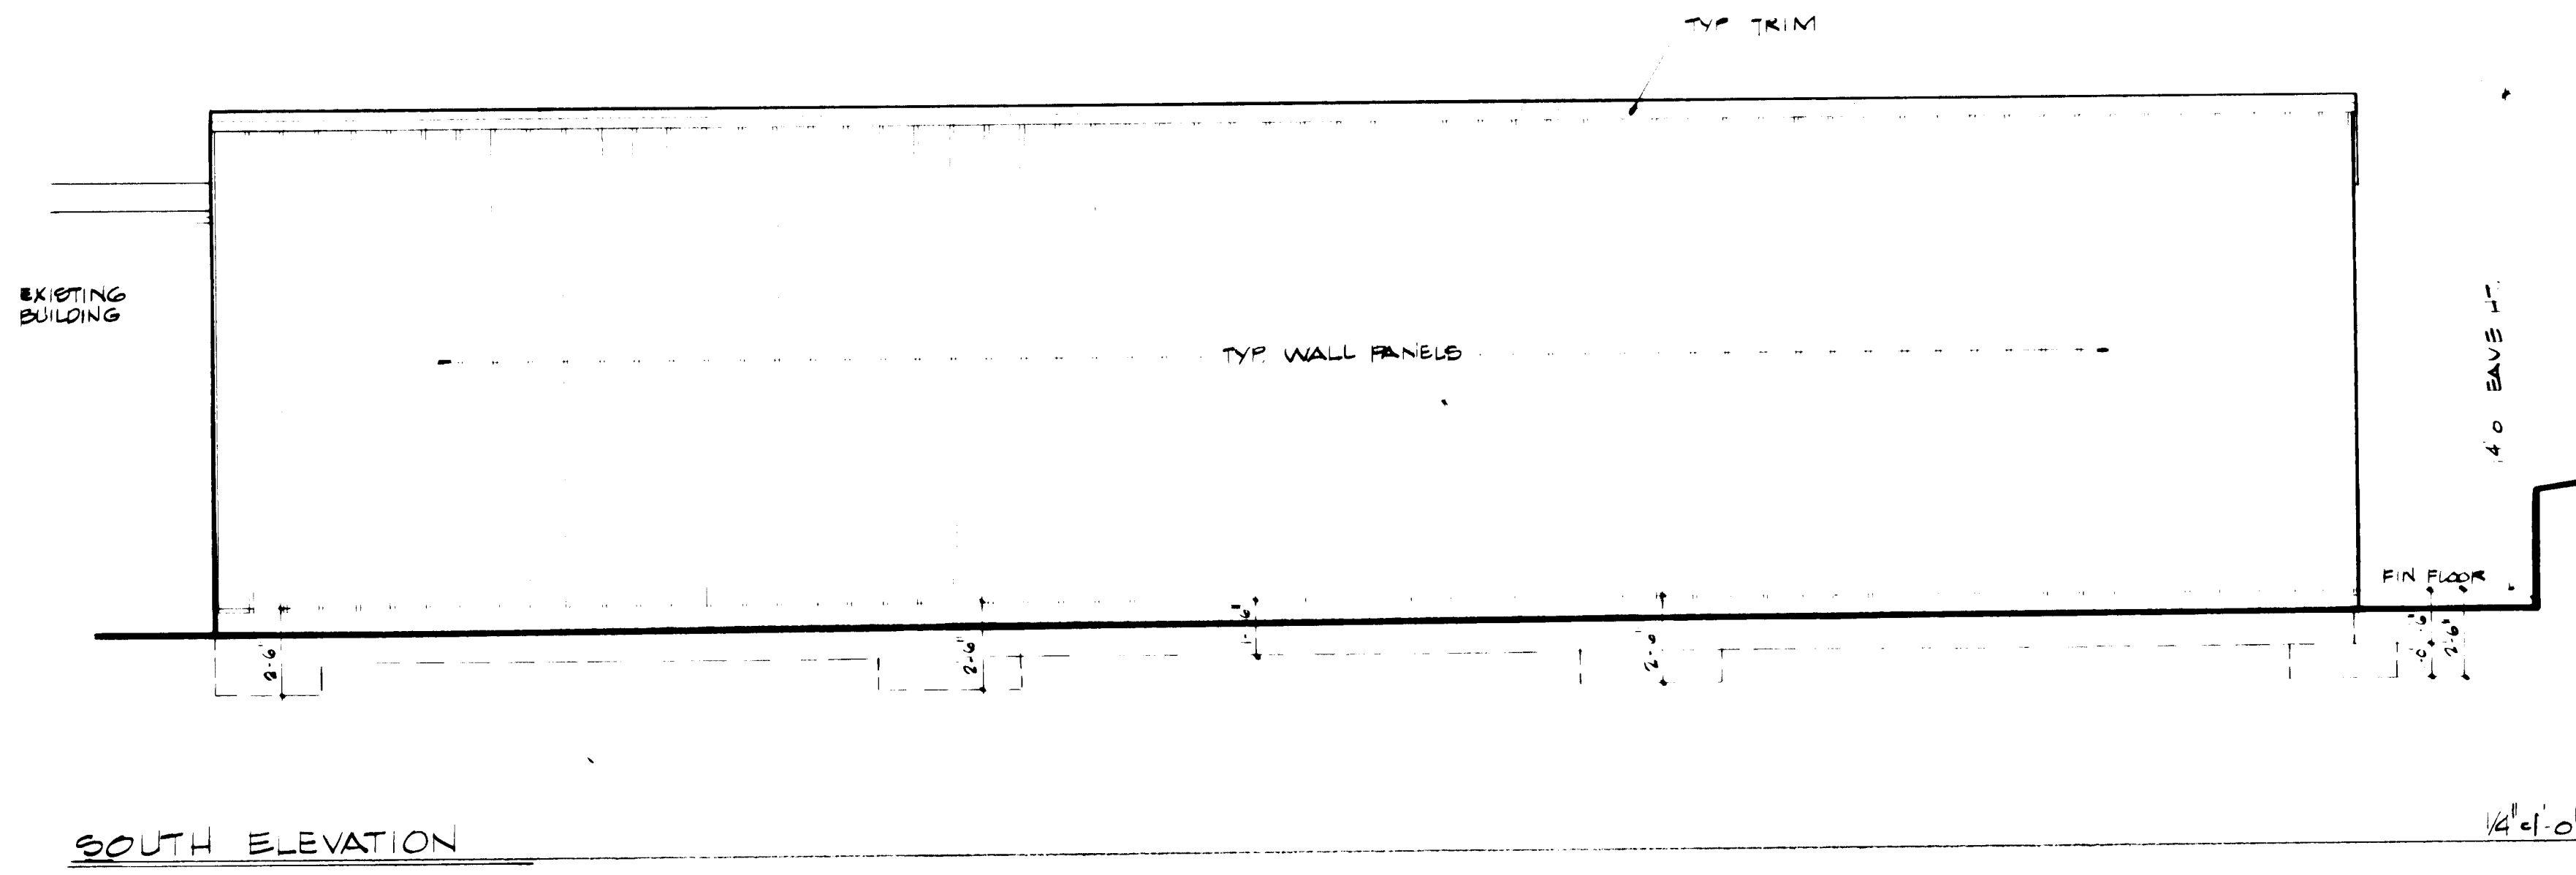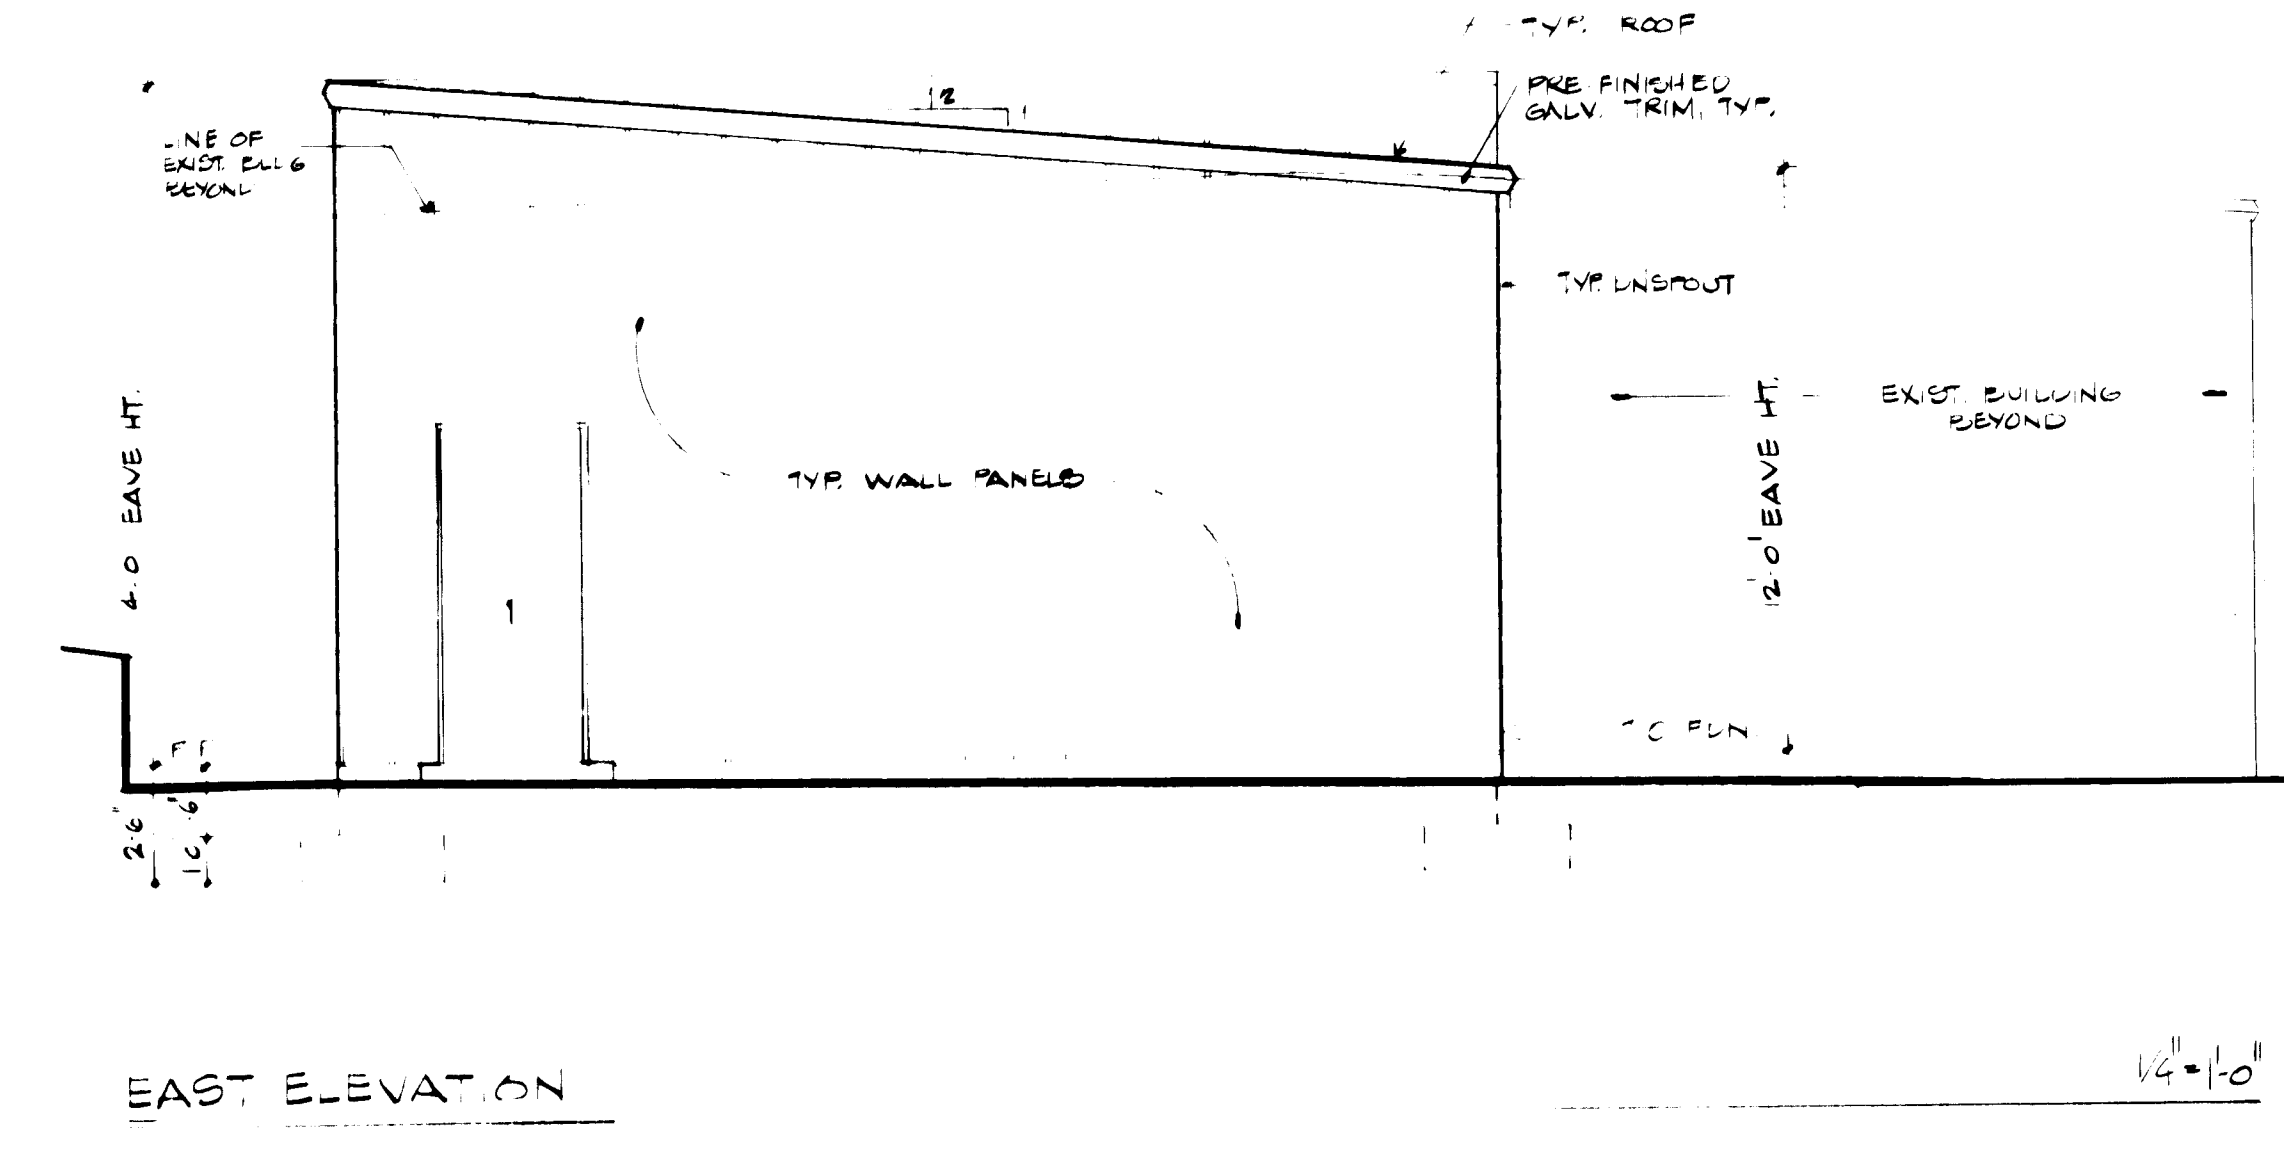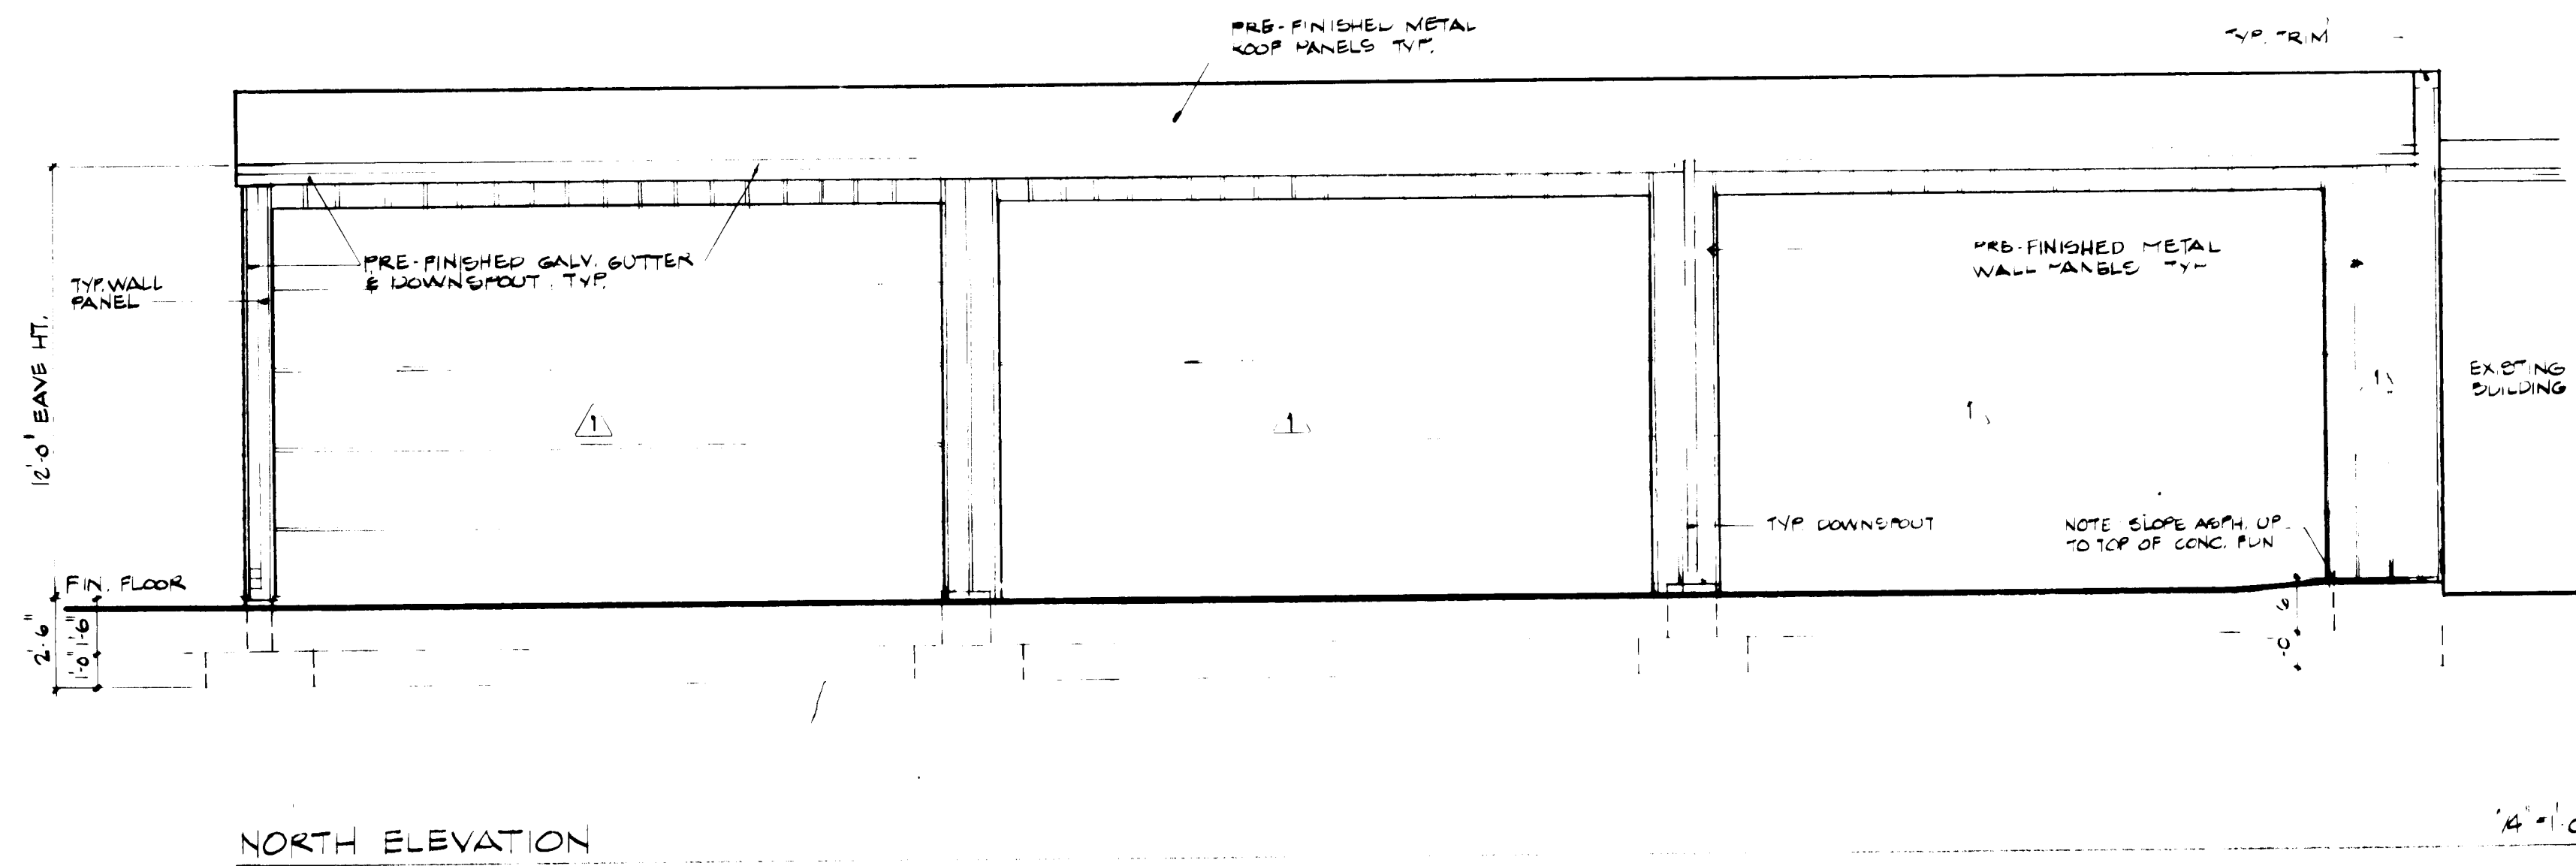




P A-6 BUILDING SECTION - TRUCK SHED

26 28071088



1-12-88

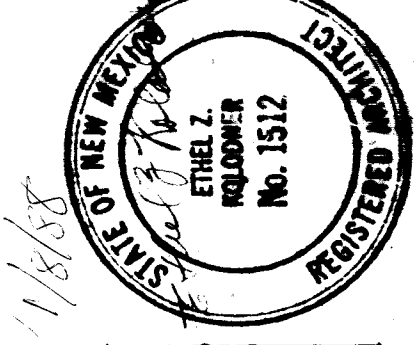

RECORD DRAWING Based on information provided by City of Albuquerque, Environmental Health Department, 1/18/88

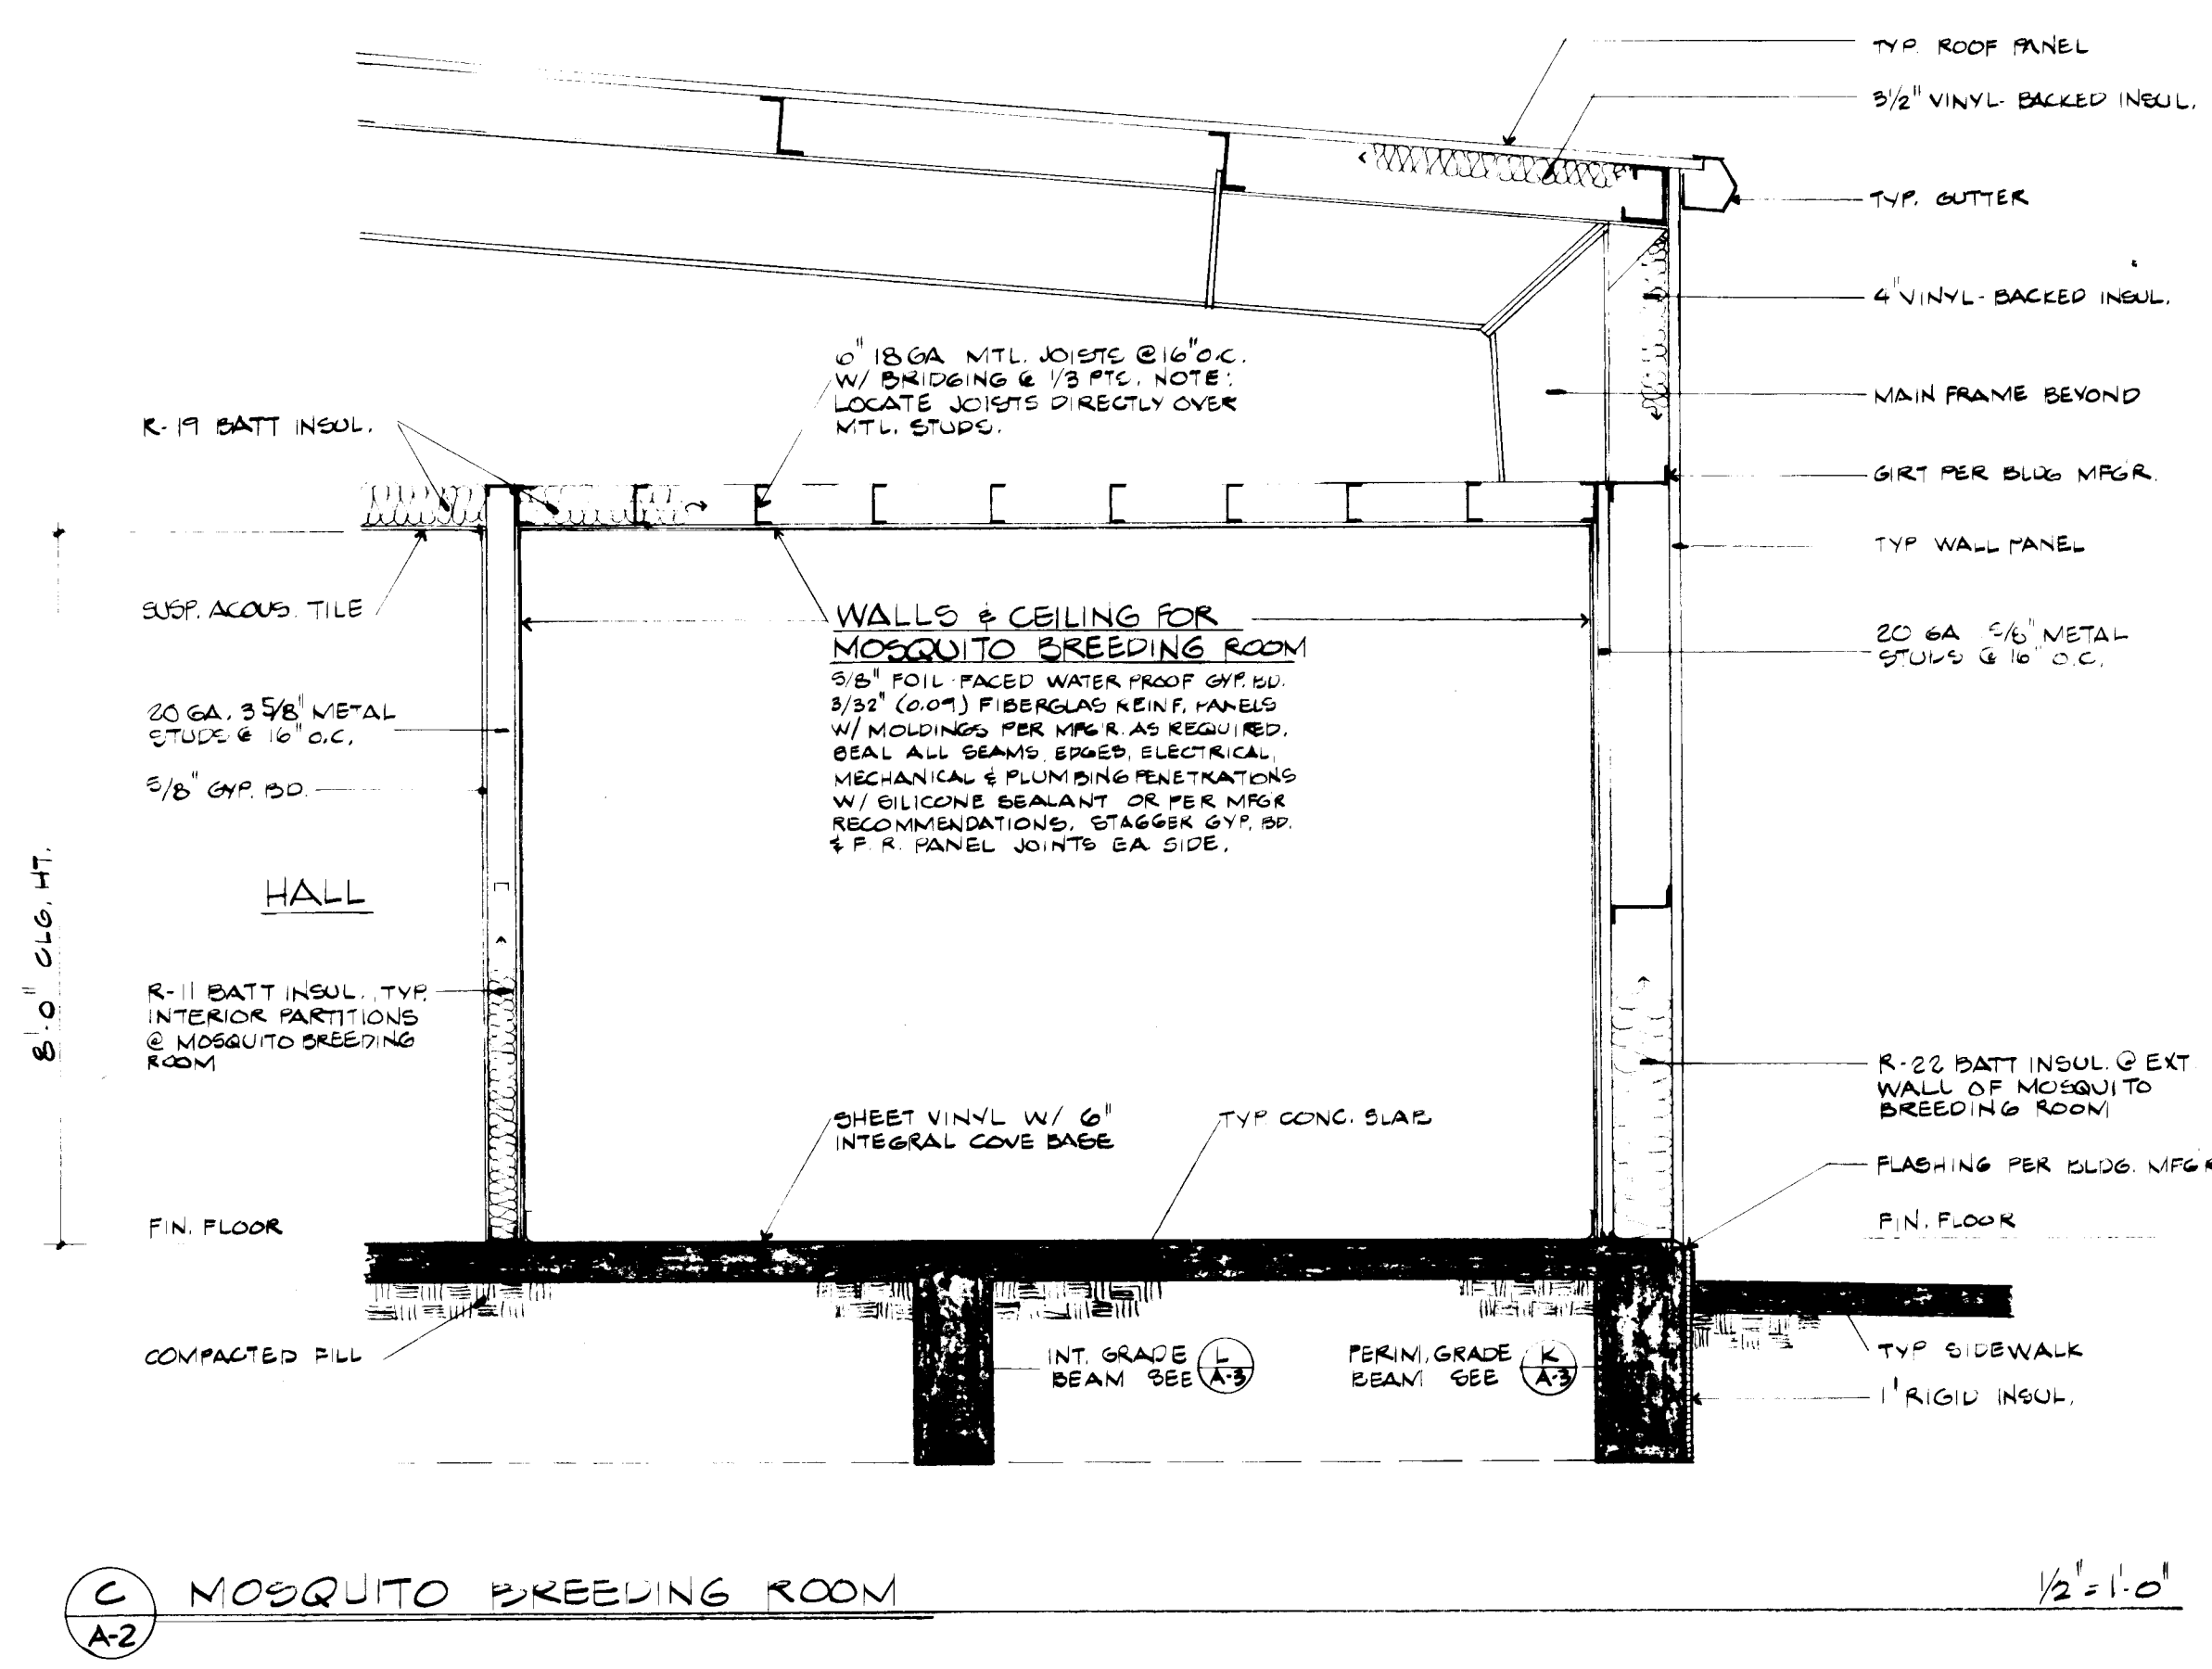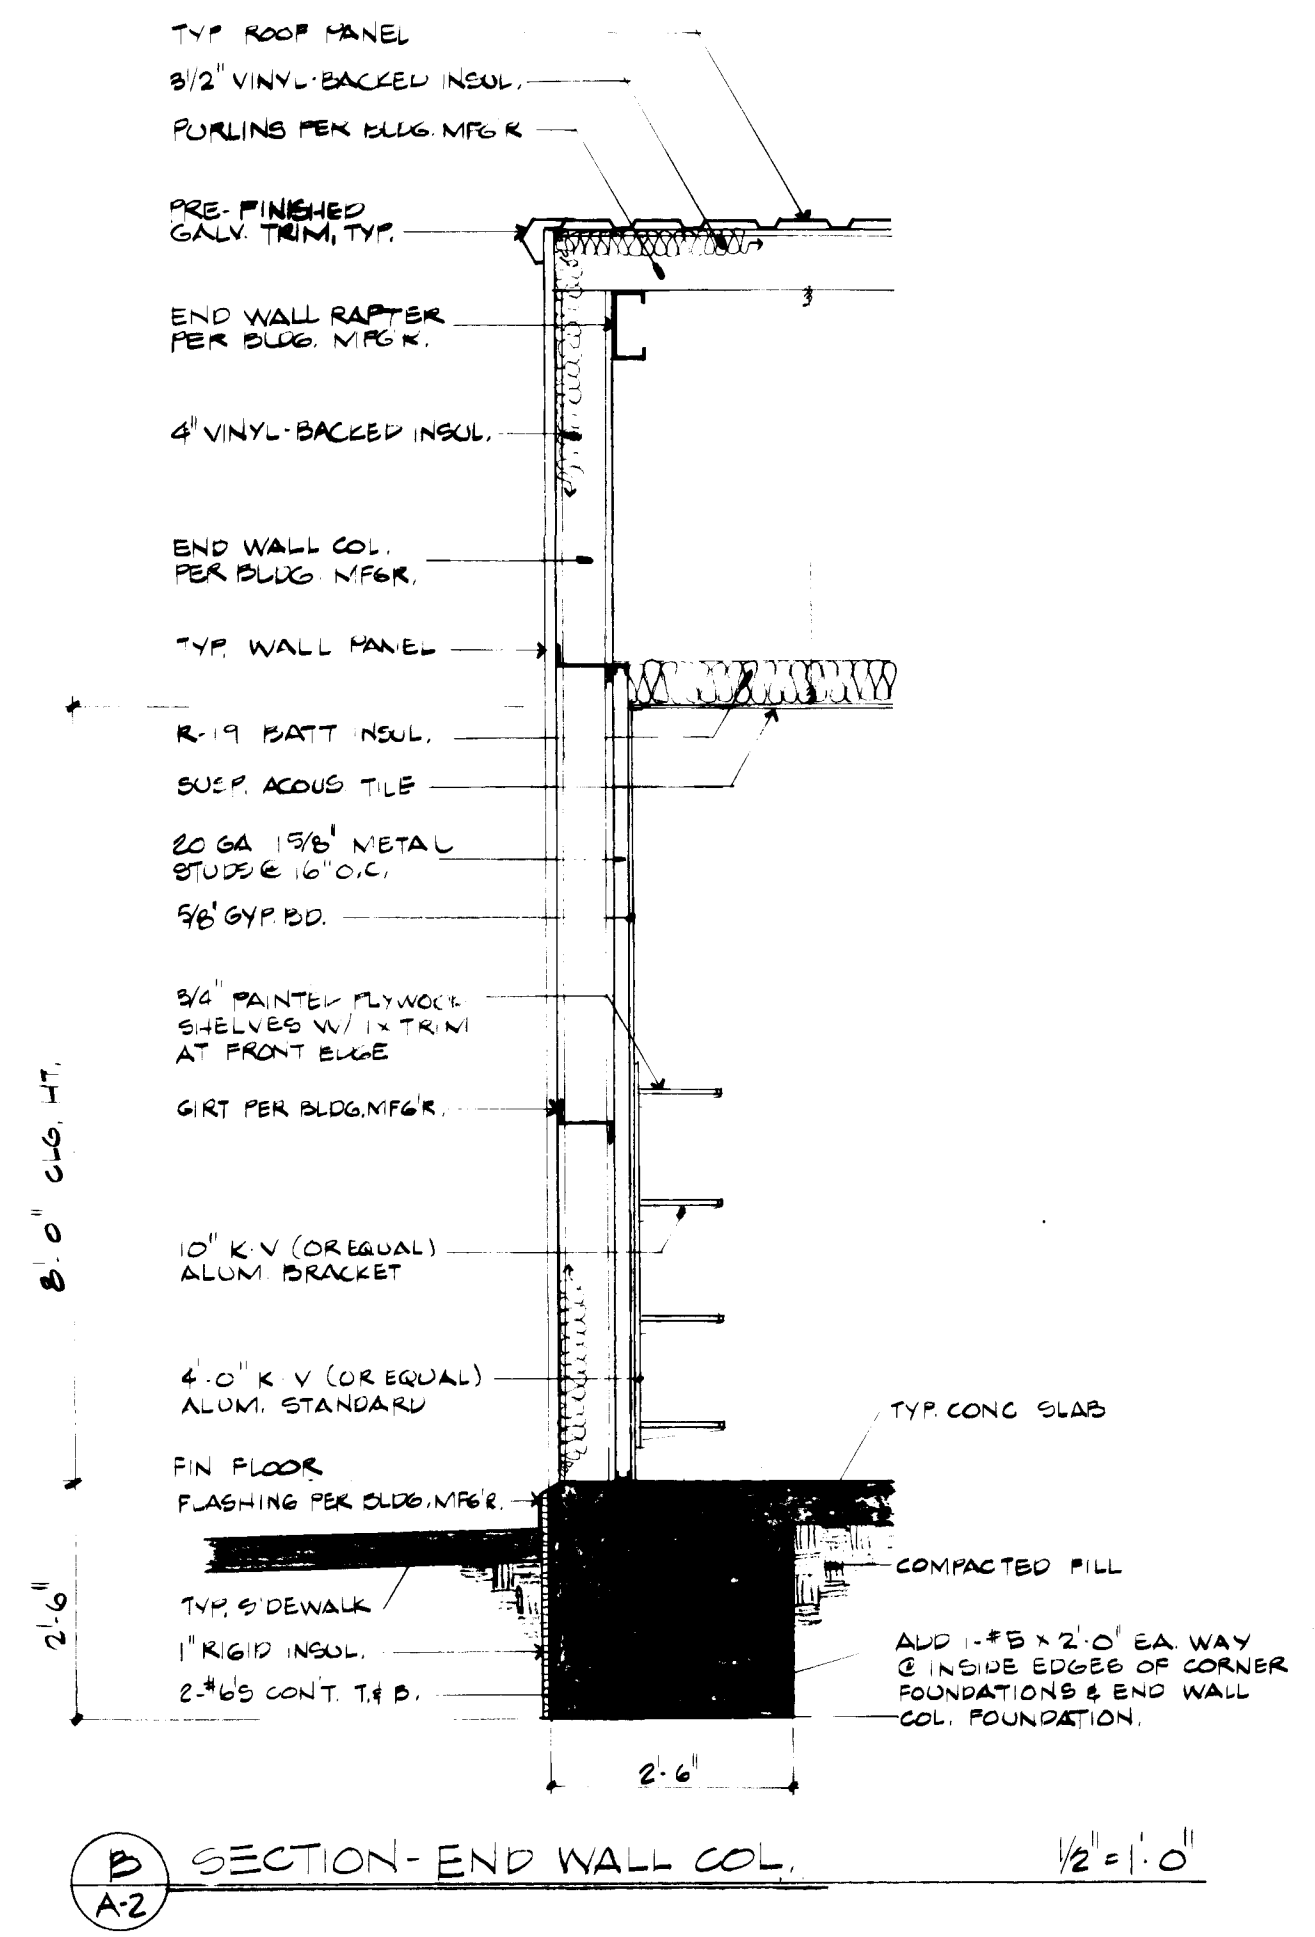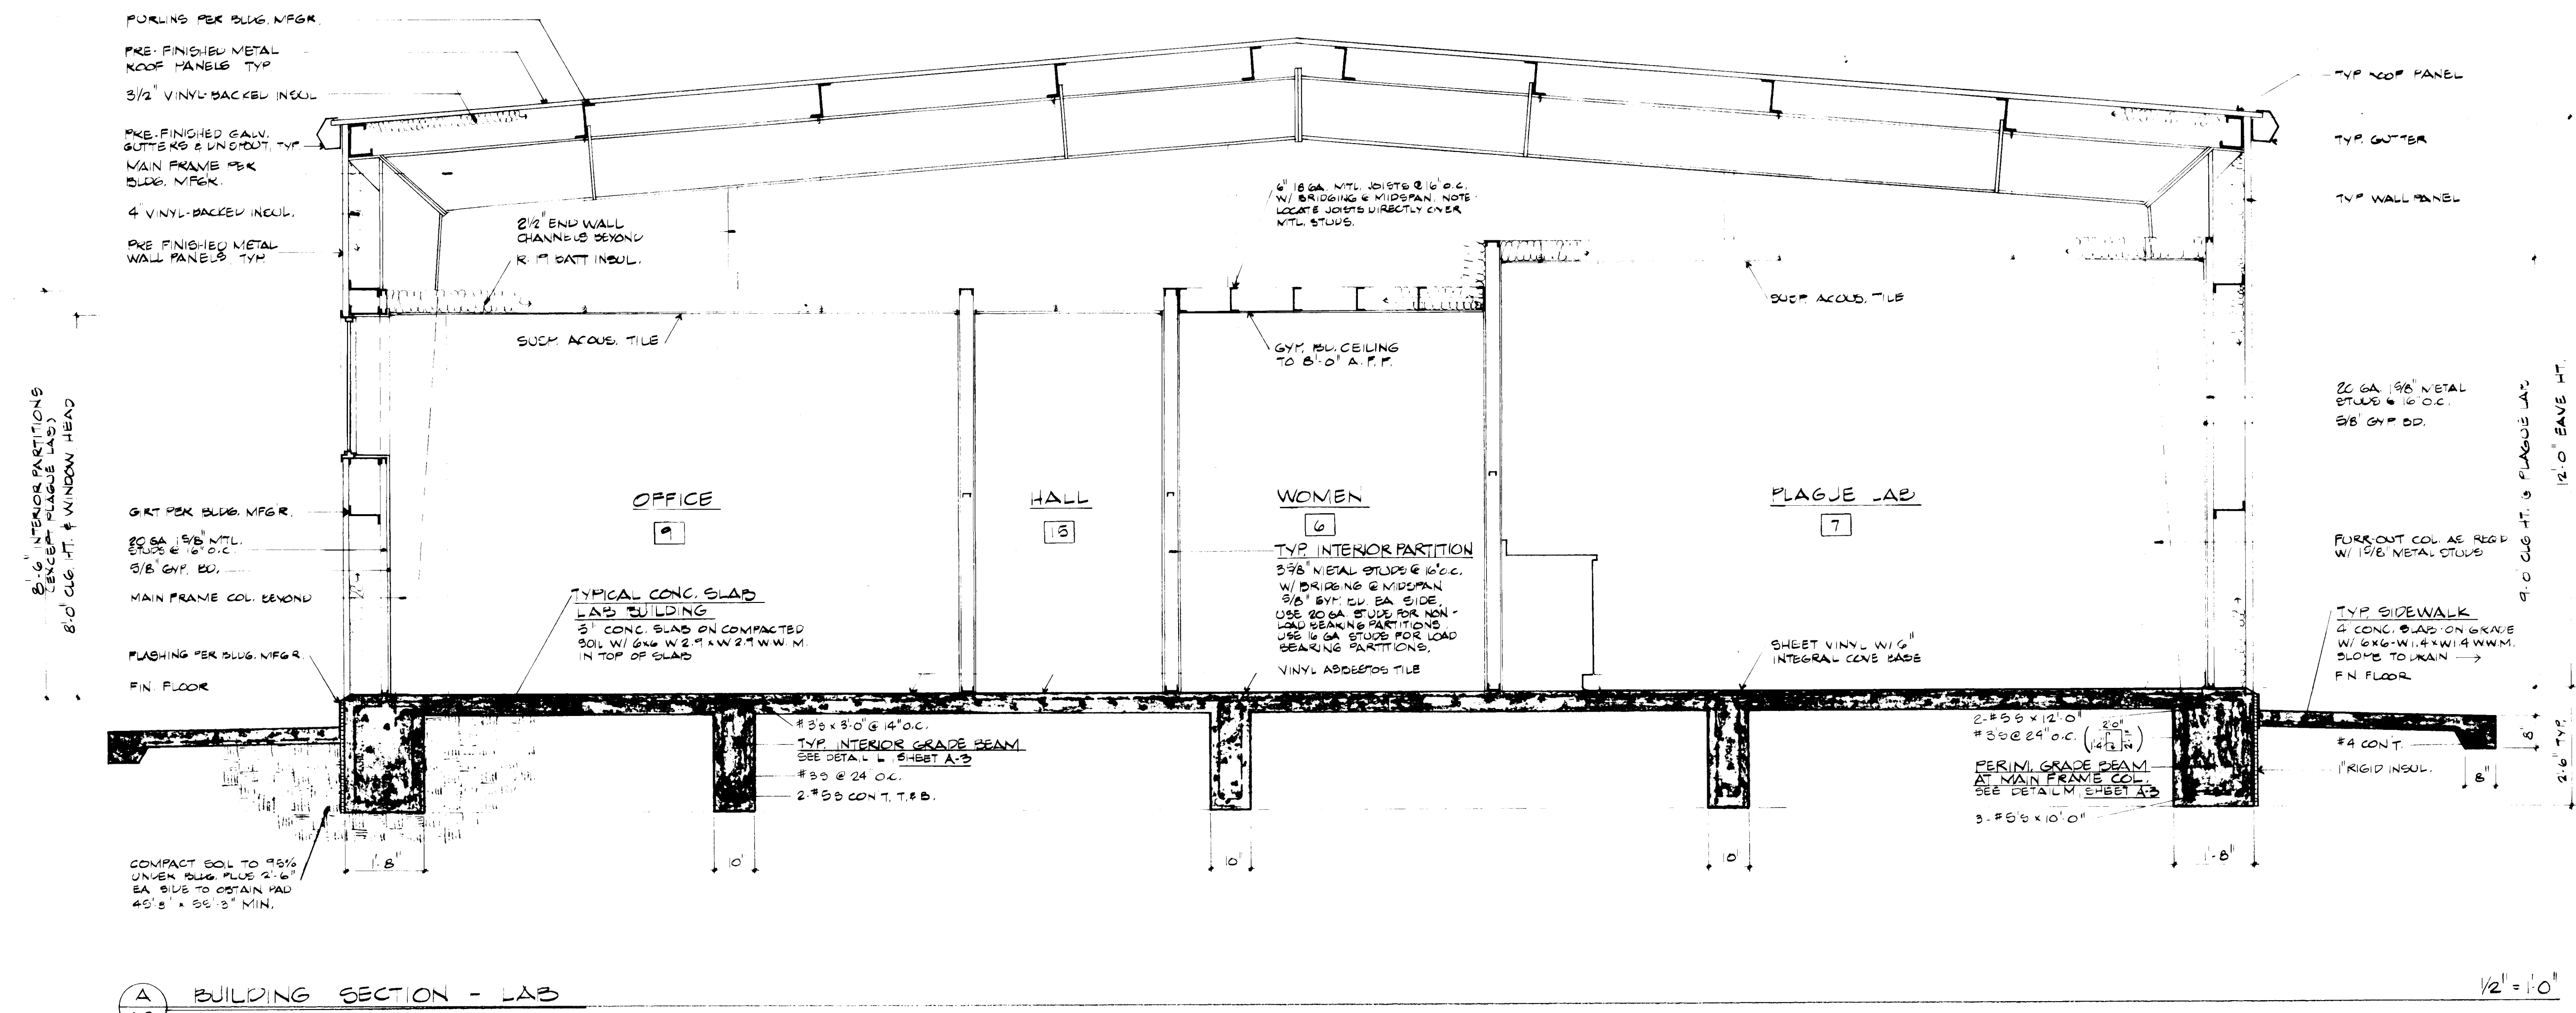

26 28070788

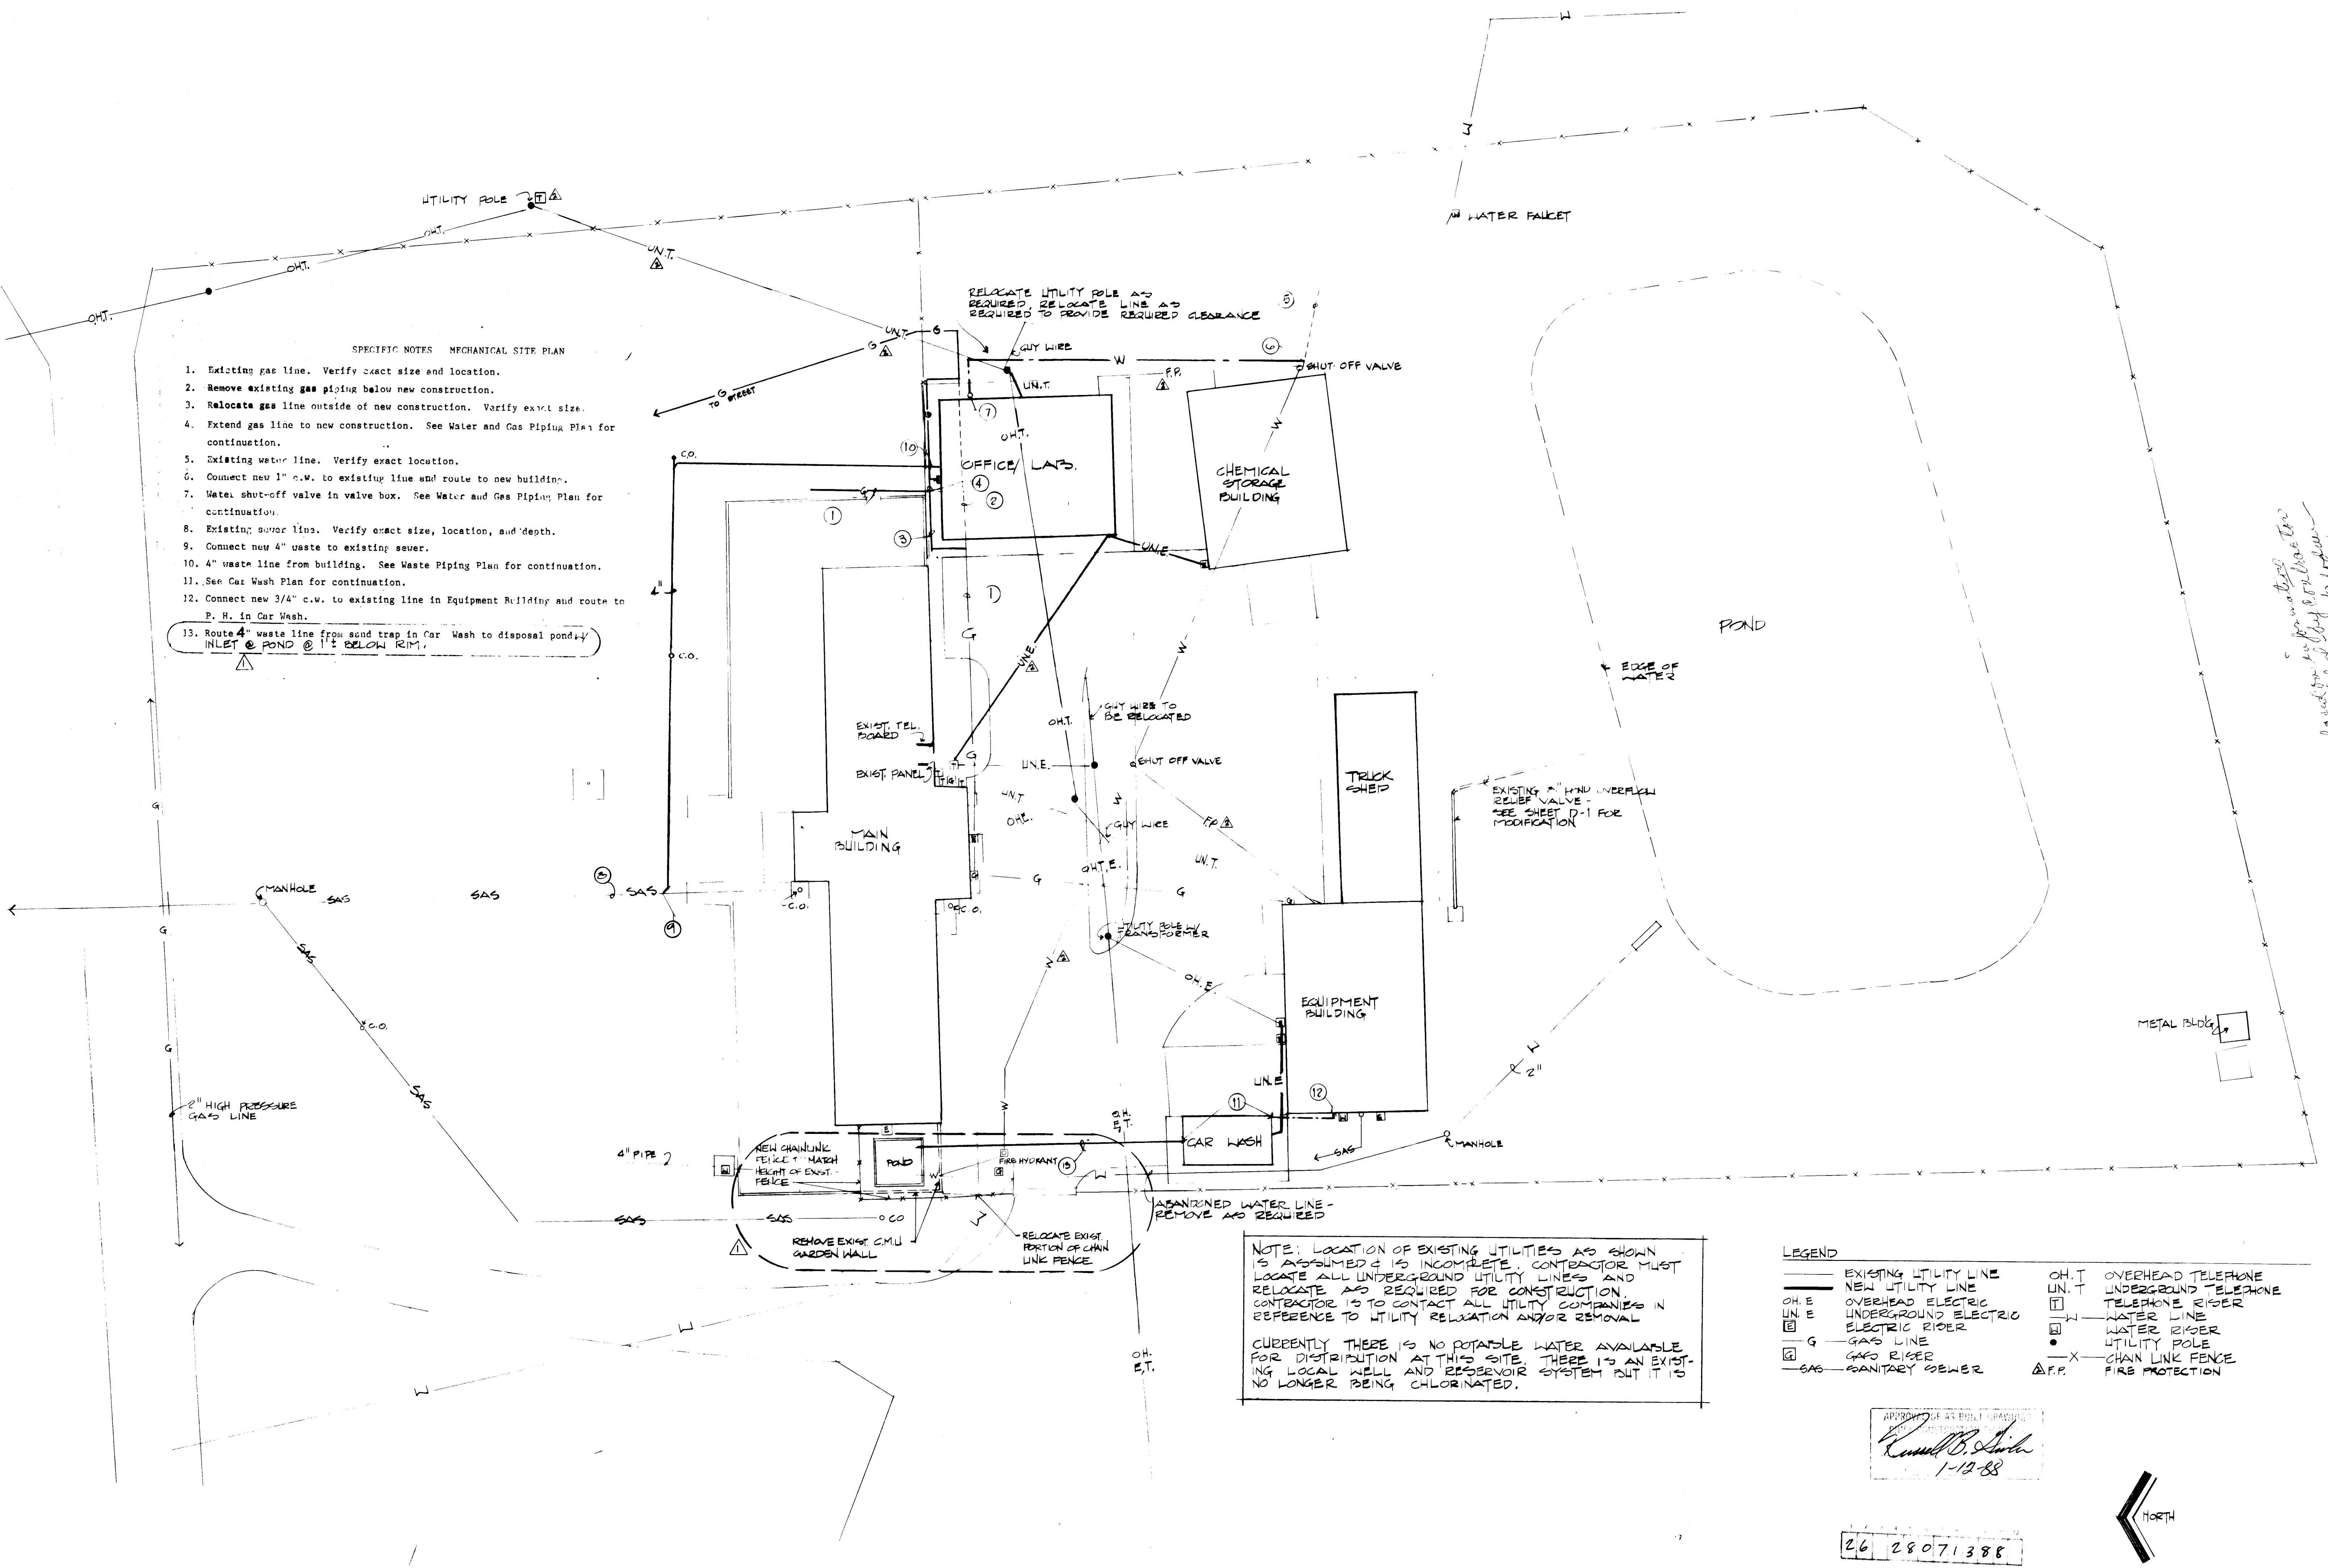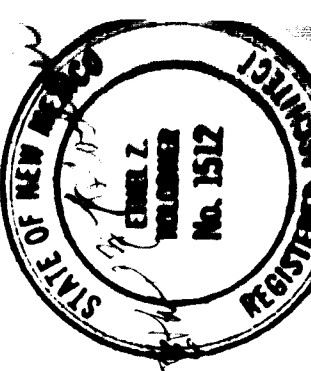

- SPECIFIC NOTES MECHANICAL SITE PLAN
1. Existing gas line. Verify exact size and location.
 2. Remove existing gas piping below new construction.
 3. Relocate gas line outside of new construction. Verify exact size.
 4. Extend gas line to new construction. See Water and Gas Piping Plan for continuation.
 5. Existing water line. Verify exact location.
 6. Connect new 1" c.w. to existing line and route to new building.
 7. Water shut-off valve in valve box. See Water and Gas Piping Plan for continuation.
 8. Existing sewer line. Verify exact size, location, and depth.
 9. Connect new 4" waste to existing sewer.
 10. 4" waste line from building. See Waste Piping Plan for continuation.
 11. See Car Wash Plan for continuation.
 12. Connect new 3/4" c.w. to existing line in Equipment Building and route to P. H. in Car Wash.
 13. Route 4" waste line from sand trap in Car Wash to disposal pond. INLET @ POND @ 1' BELOW RIM.

NOTE: LOCATION OF EXISTING UTILITIES AS SHOWN IS ASSUMED & IS INCOMPLETE. CONTRACTOR MUST LOCATE ALL UNDERGROUND UTILITY LINES AND RELOCATE AS REQUIRED FOR CONSTRUCTION. CONTRACTOR IS TO CONTACT ALL UTILITY COMPANIES IN REFERENCE TO UTILITY RELAXATION AND/OR REMOVAL.




CURRENTLY THERE IS NO POTABLE WATER AVAILABLE FOR DISTRIBUTION AT THIS SITE. THERE IS AN EXISTING LOCAL WELL AND RESERVOIR SYSTEM BUT IT IS NO LONGER BEING CHLORINATED.

LEGEND

—	EXISTING UTILITY LINE	OH.T	OVERHEAD TELEPHONE
—	NEW UTILITY LINE	UN.T	UNDERGROUND TELEPHONE
OH.E	OVERHEAD ELECTRIC	TEL	TELEPHONE RIGID
UN.E	UNDERGROUND ELECTRIC	W	WATER LINE
E	ELECTRIC RIGID	WR	WATER RIGID
G	GAS LINE	U	UTILITY POLE
GR	GAS RIGID	X	CHAIN LINK FENCE
SAS	SANITARY SEWER	Δ F.P.	FIRE PROTECTION

APPROVED AS BUILT DRAWING
Russell B. Smith
1-12-88

26 28071388

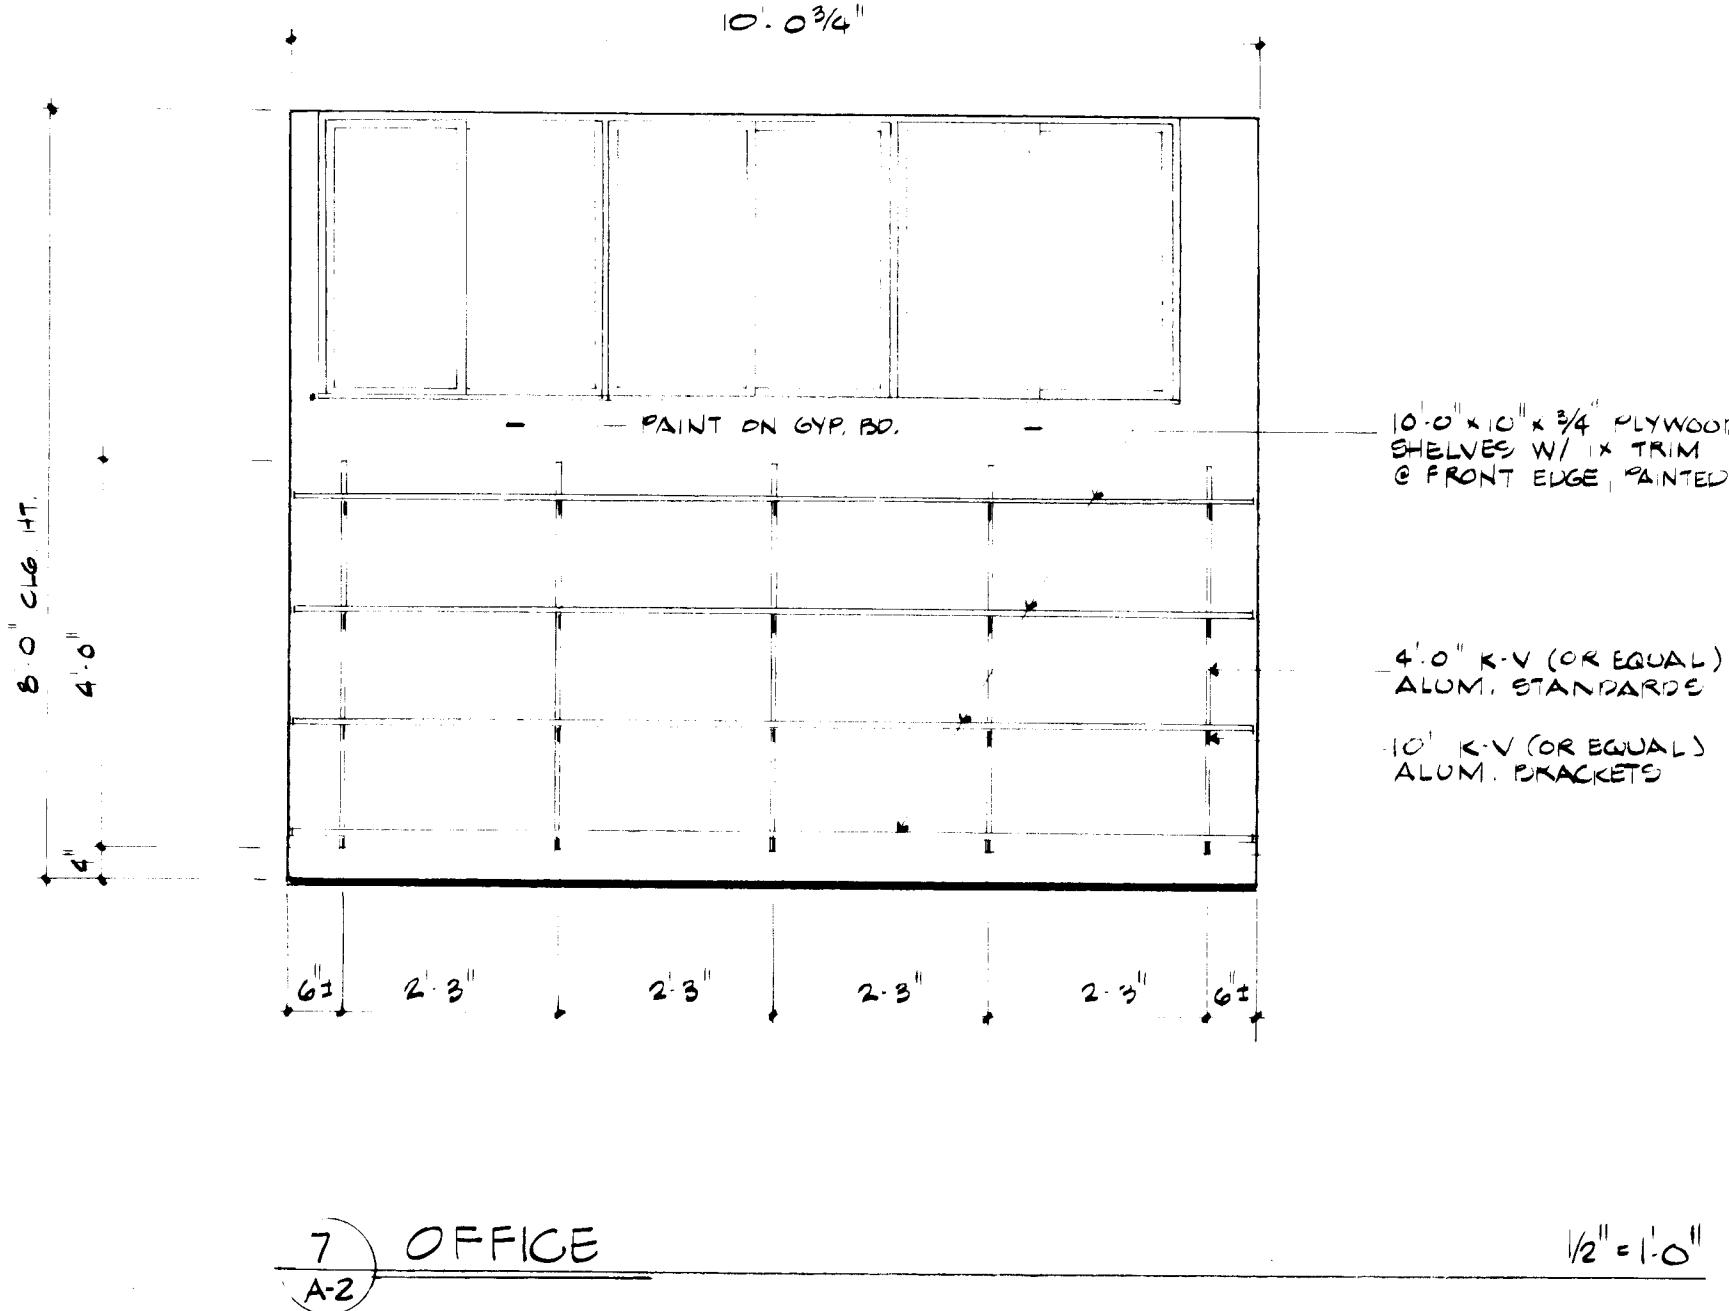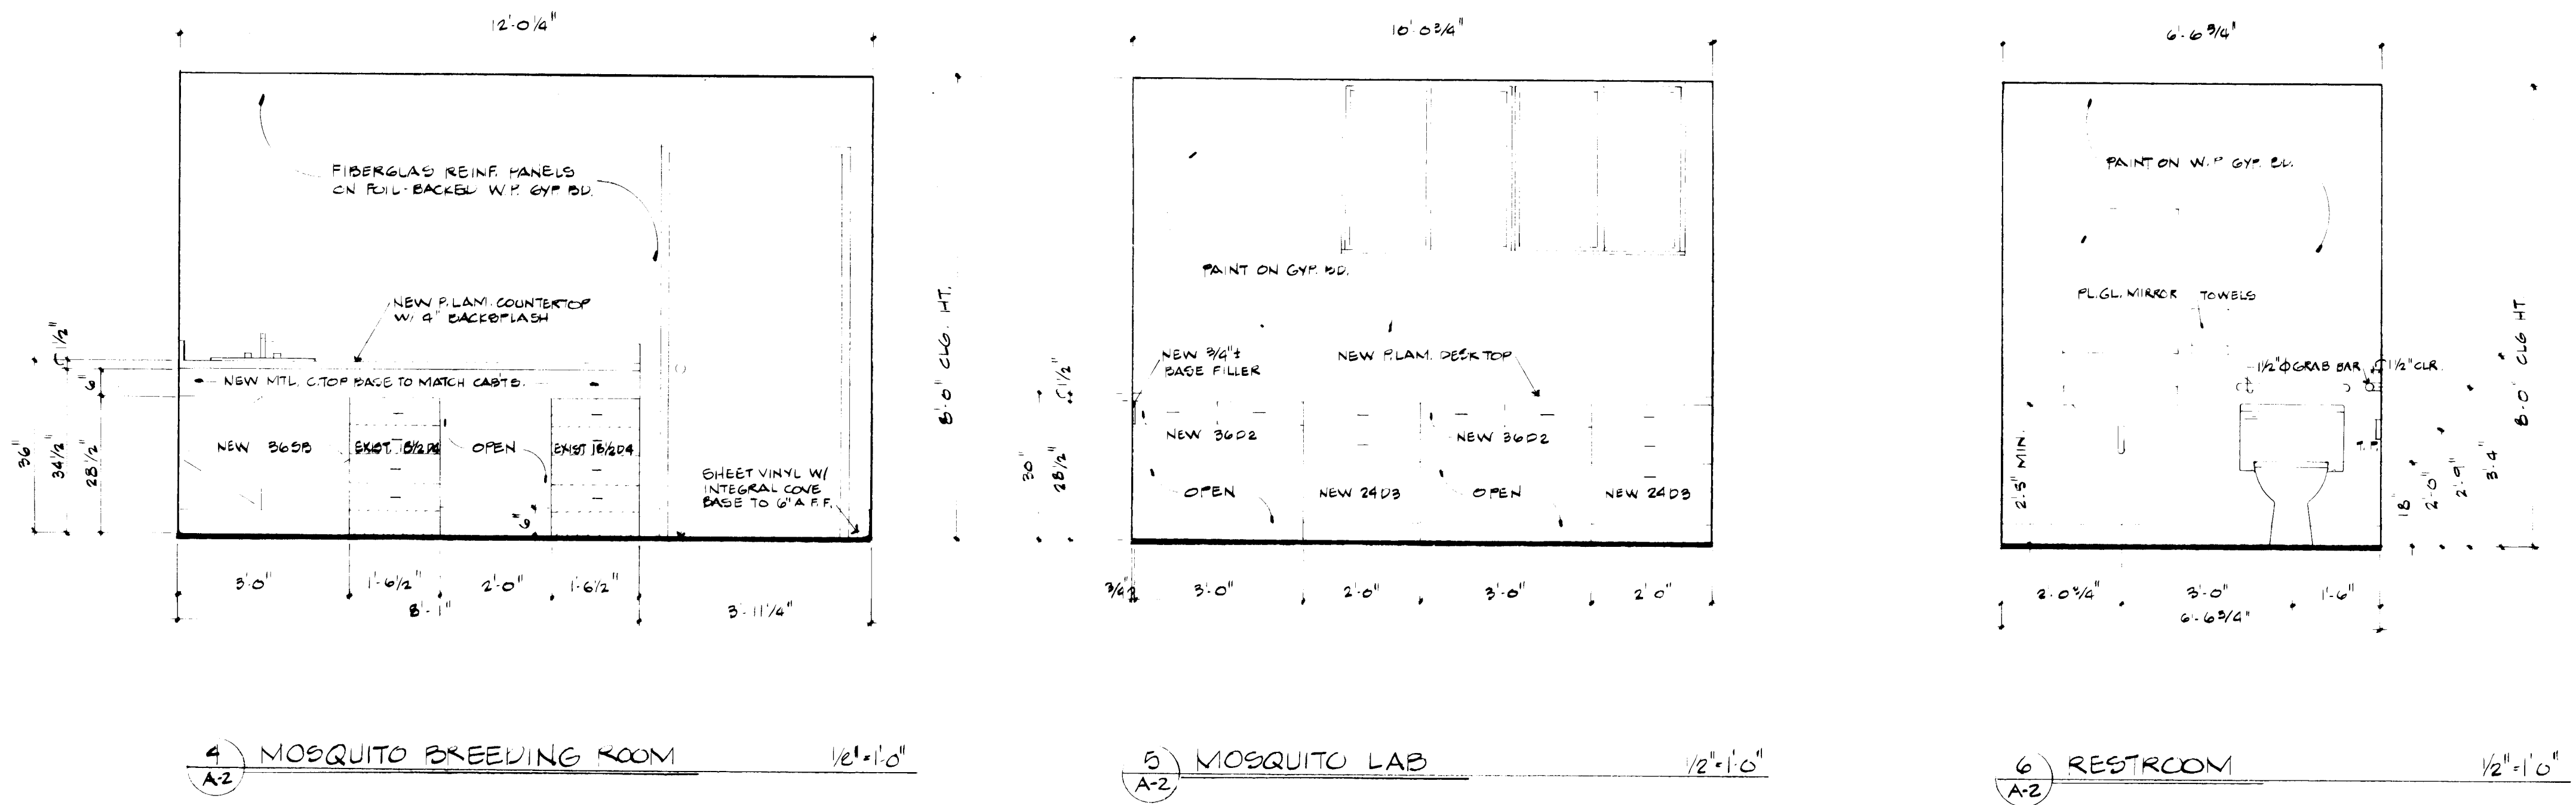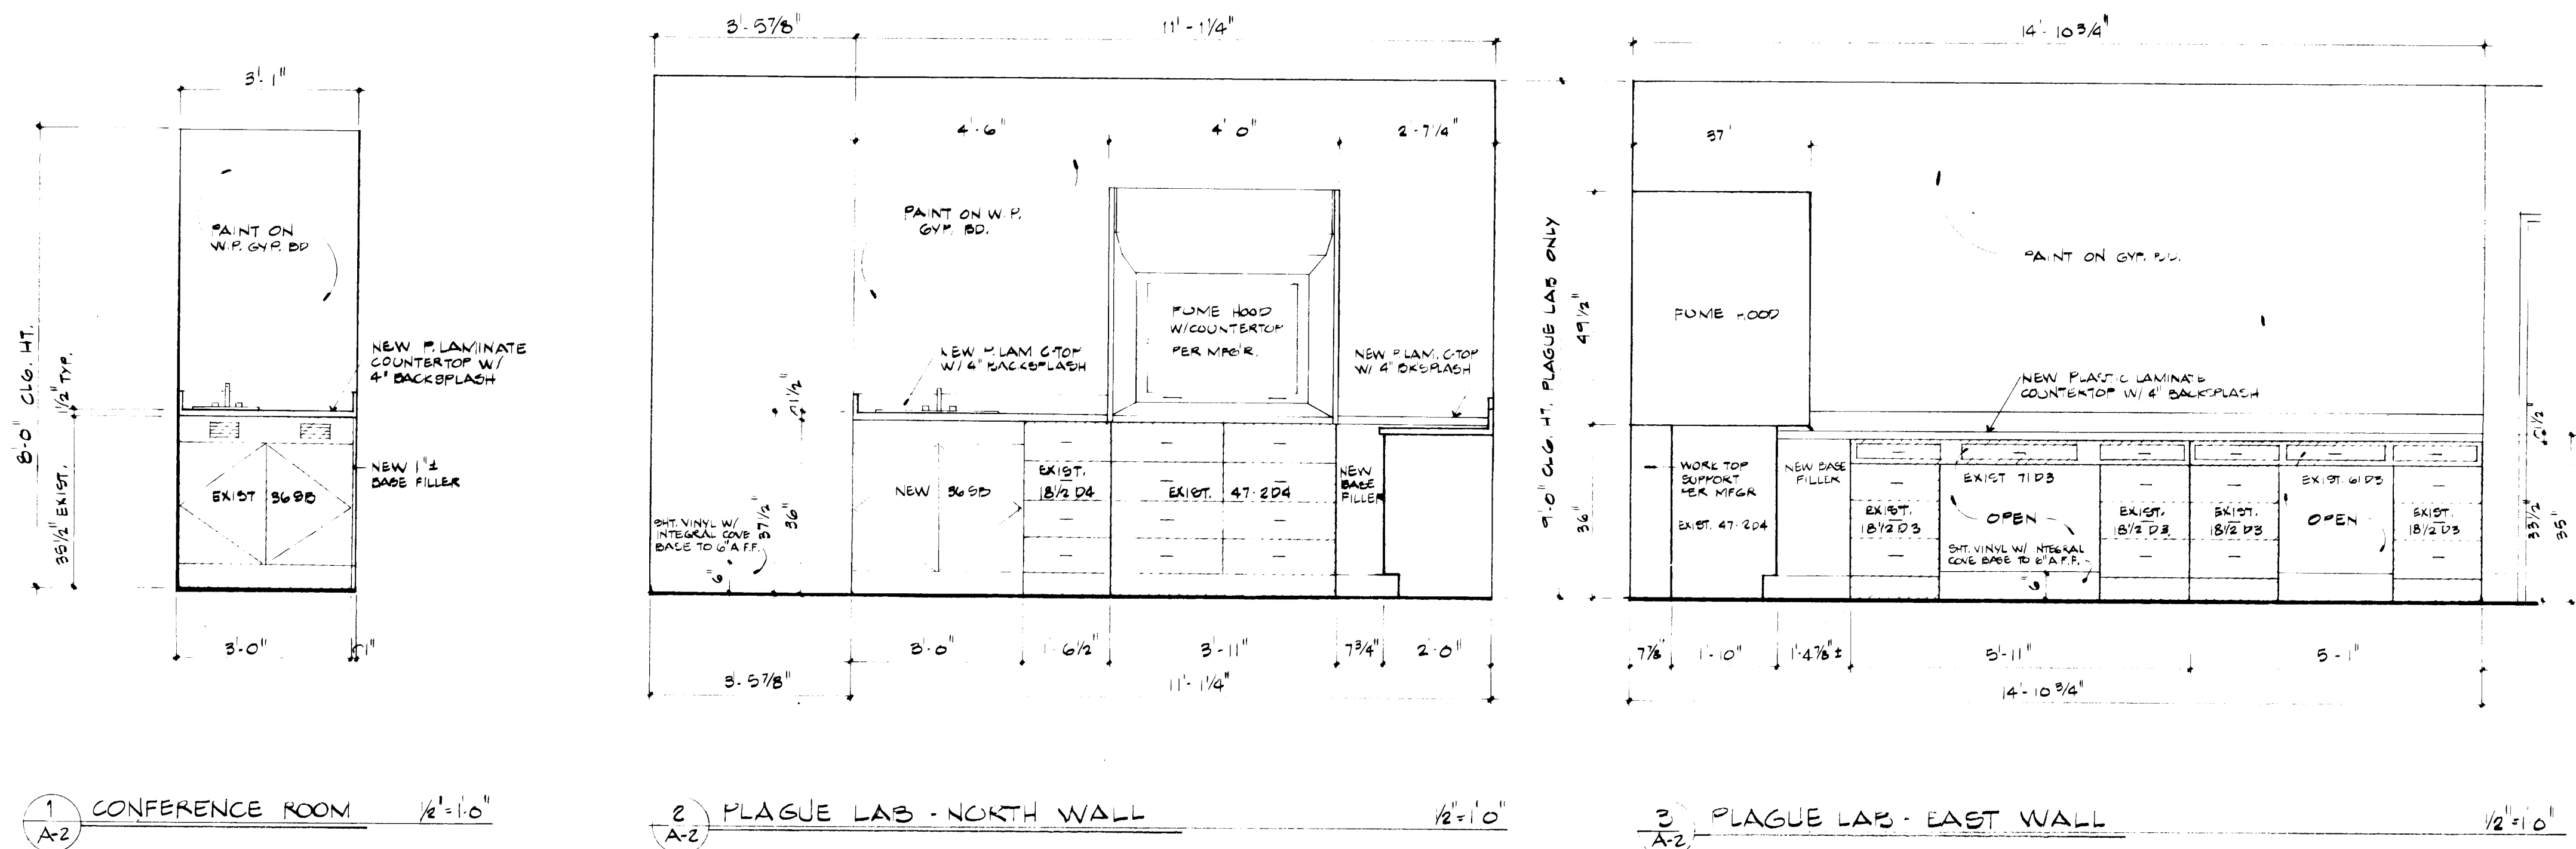


NOTES:


1. DIMENSIONS GIVEN ON INTERIOR ELEVATIONS ARE FINISHED DIMENSIONS. VERIFY ALL DIMENSIONS IN THE FIELD.
2. VERIFY SIZE OF ALL EXISTING CABINETS TO BE REUSED.
3. ALL EXISTING METAL CABINETS TO BE REUSED SHALL BE CLEANED AND MAINTAINED.
4. NEW CABINETS SHALL MATCH EXISTING.

ROOM	FLOOR	BASE	WALL	CEILING	CEILING HT.	REMARKS
1 CONFERENCE						
2 JANITOR CLO.						
3 FURNACE						
4 OFFICE						
5 MEN						
6 WOMEN						
7 PLAGUE LAB						
8 STORAGE						
9 OFFICE						
10 MOSQ. BREED.						
11 STORAGE						
12 MOSQUITO LAB						
13 OFFICE						
14 OFFICE						
15 HALL						


SIZE	FRAME	TYPE	GLAZING	REMARKS
A 3'0" x 3'0"	ALUM.	SLIDER	DOUBLE	PER BLDG. MFR.
B 2'6" x 3'0"	ALUM.	SLIDER	DOUBLE	PER BLDG. MFR.
C 3'6" x 3'0"	ALUM.	SLIDER	DOUBLE	PER BLDG. MFR.

NO.	SIZE	TYPE	H WARE	FRAME	THRESHOLD	REMARKS
1	3'0" x 7'0" x 1 3/4"	A	1	*		* PER BLDG. MFR.
2	3'0" x 6'6" x 1 3/4"	B	3	2" H.M.		
3	3'0" x 6'6" x 1 3/4"	C	2	WOOD		BIFOLD
4	3'0" x 6'6" x 1 3/4"	D	3	2" H.M.		
5	3'0" x 6'6" x 1 3/4"	B	3			
6	3'0" x 6'6" x 1 3/4"	C	4			INSTALL SIGN
7	3'0" x 6'6" x 1 3/4"	E	3			
8	3'0" x 6'6" x 1 3/4"	L	4			INSTALL SIGN
9	3'0" x 6'6" x 1 3/4"	A	3			W/ DOOR BOTTOM SEAL
10	3'0" x 6'6" x 1 3/4"	E	3			
11	3'0" x 6'6" x 1 3/4"	B	5			
12	3'0" x 6'6" x 1 3/4"	B	3			
13	3'0" x 6'6" x 1 3/4"	B	3			
14	3'0" x 6'6" x 1 3/4"	B	5			
15	3'0" x 6'6" x 1 3/4"	B	3			
16	3'0" x 7'0" x 1 3/4"	A	1	*		* PER BLDG. MFR.


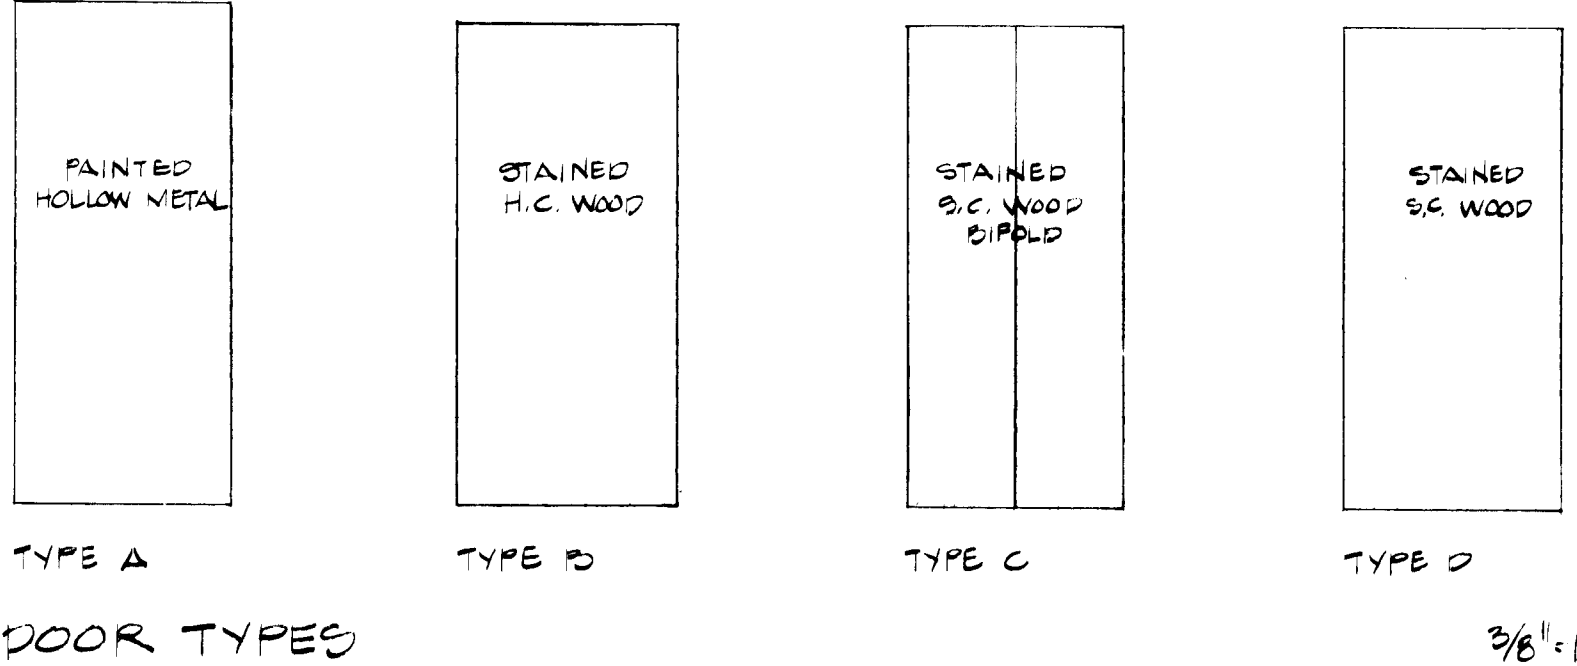


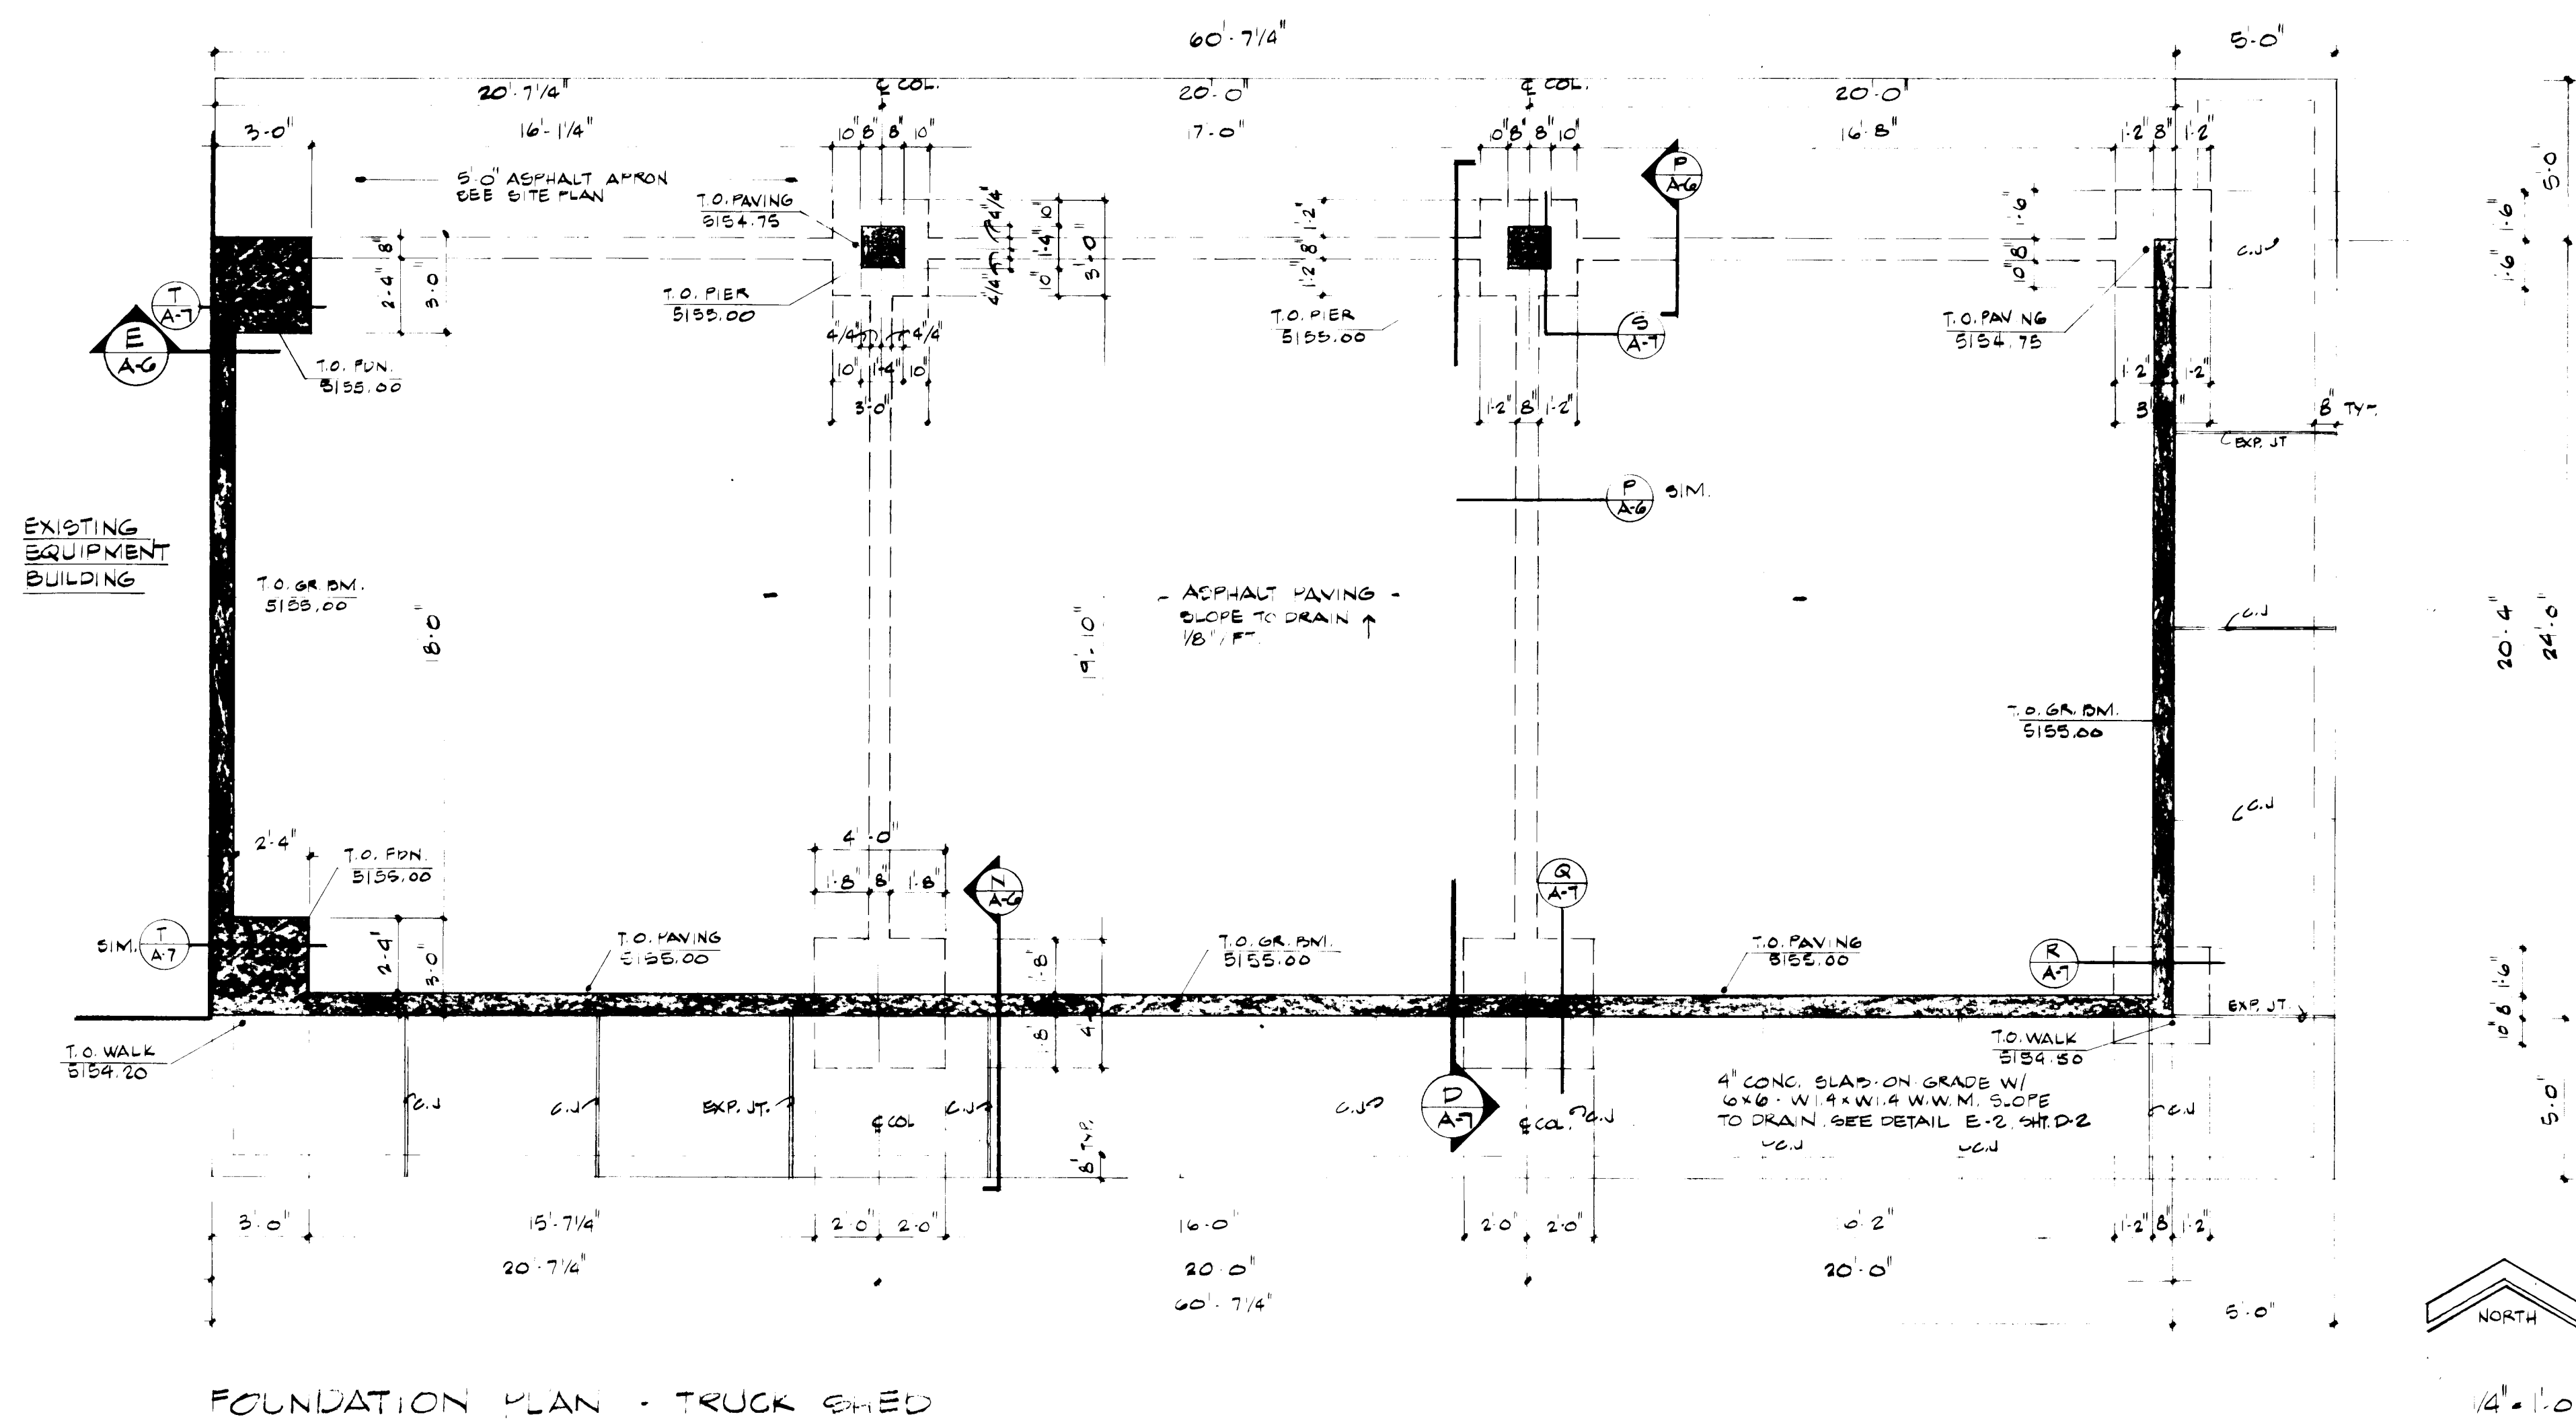





FOUNDATION PLAN - TRUCK SHED

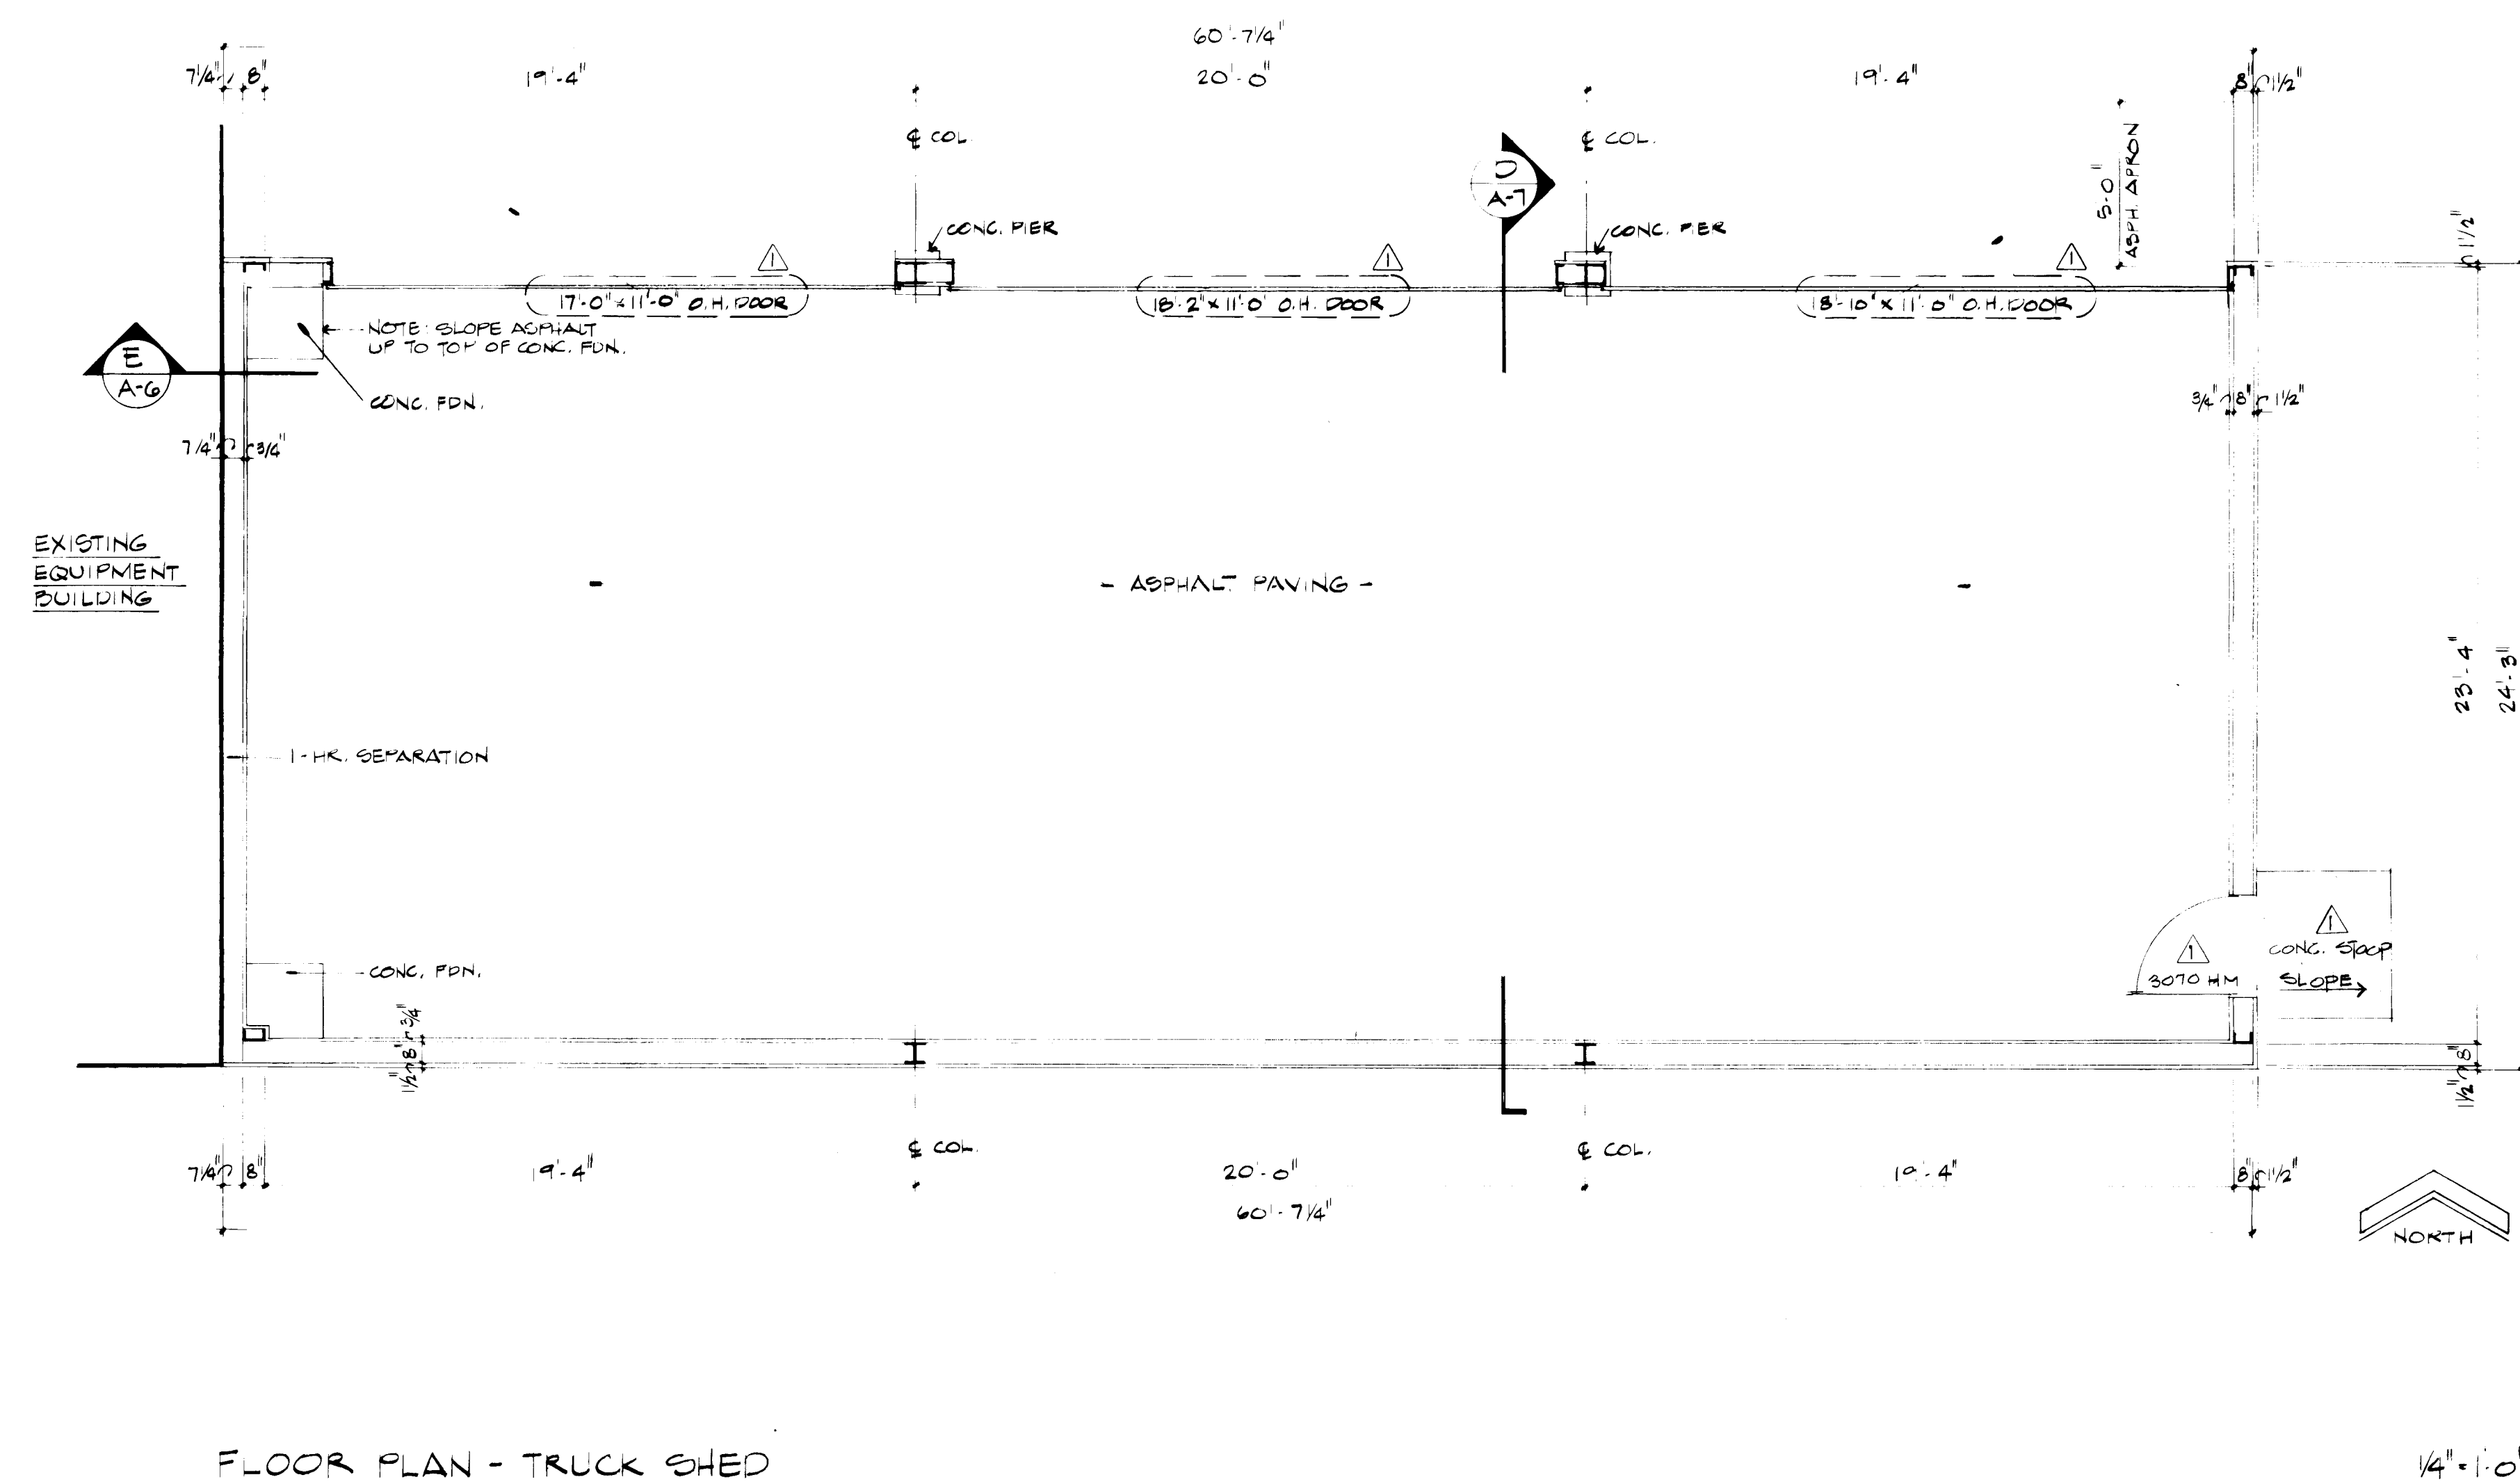

FLOOR PLAN - TRUCK SHED





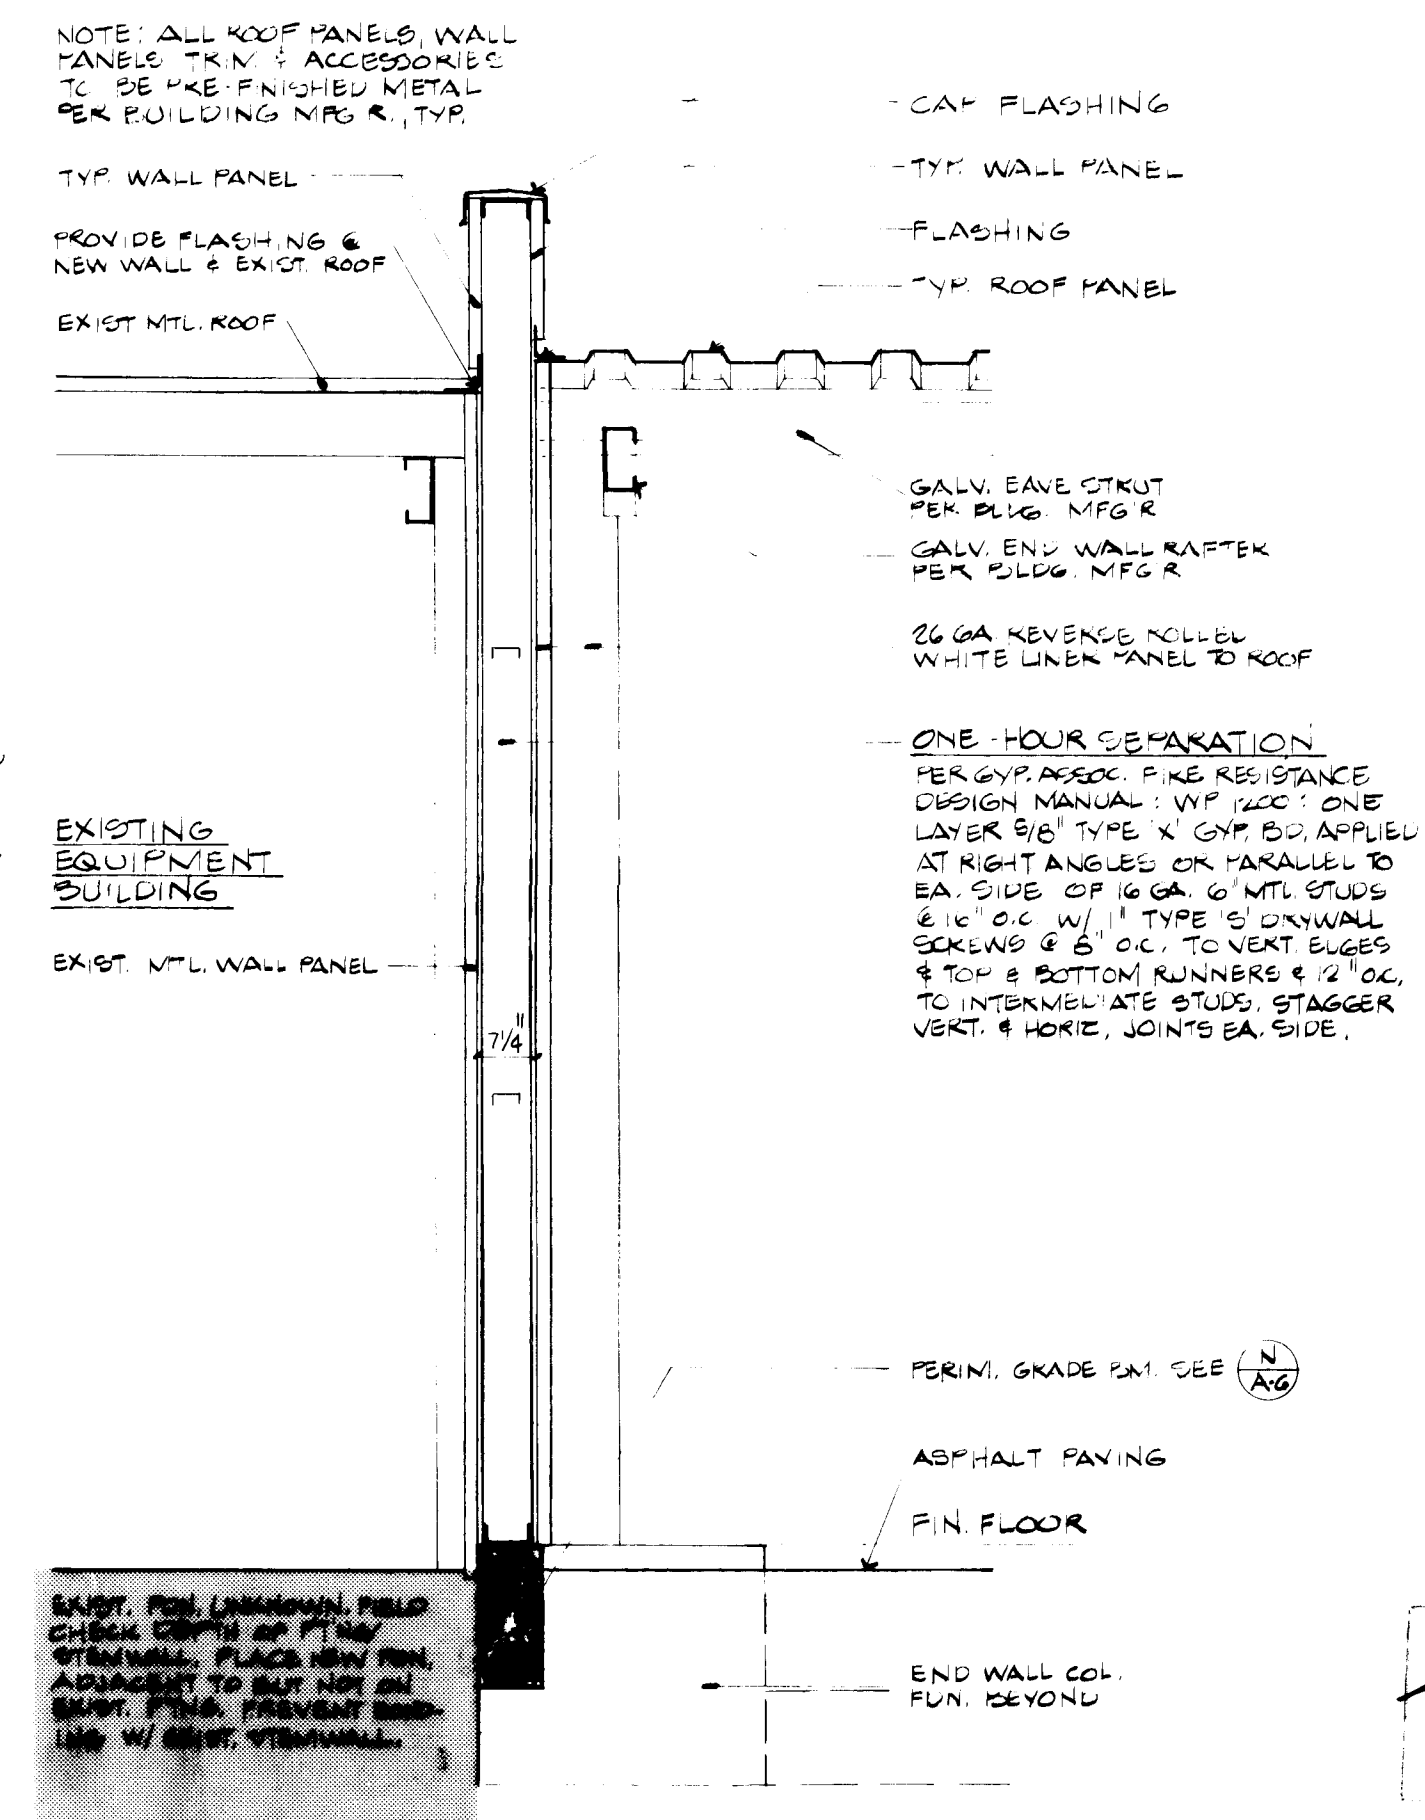
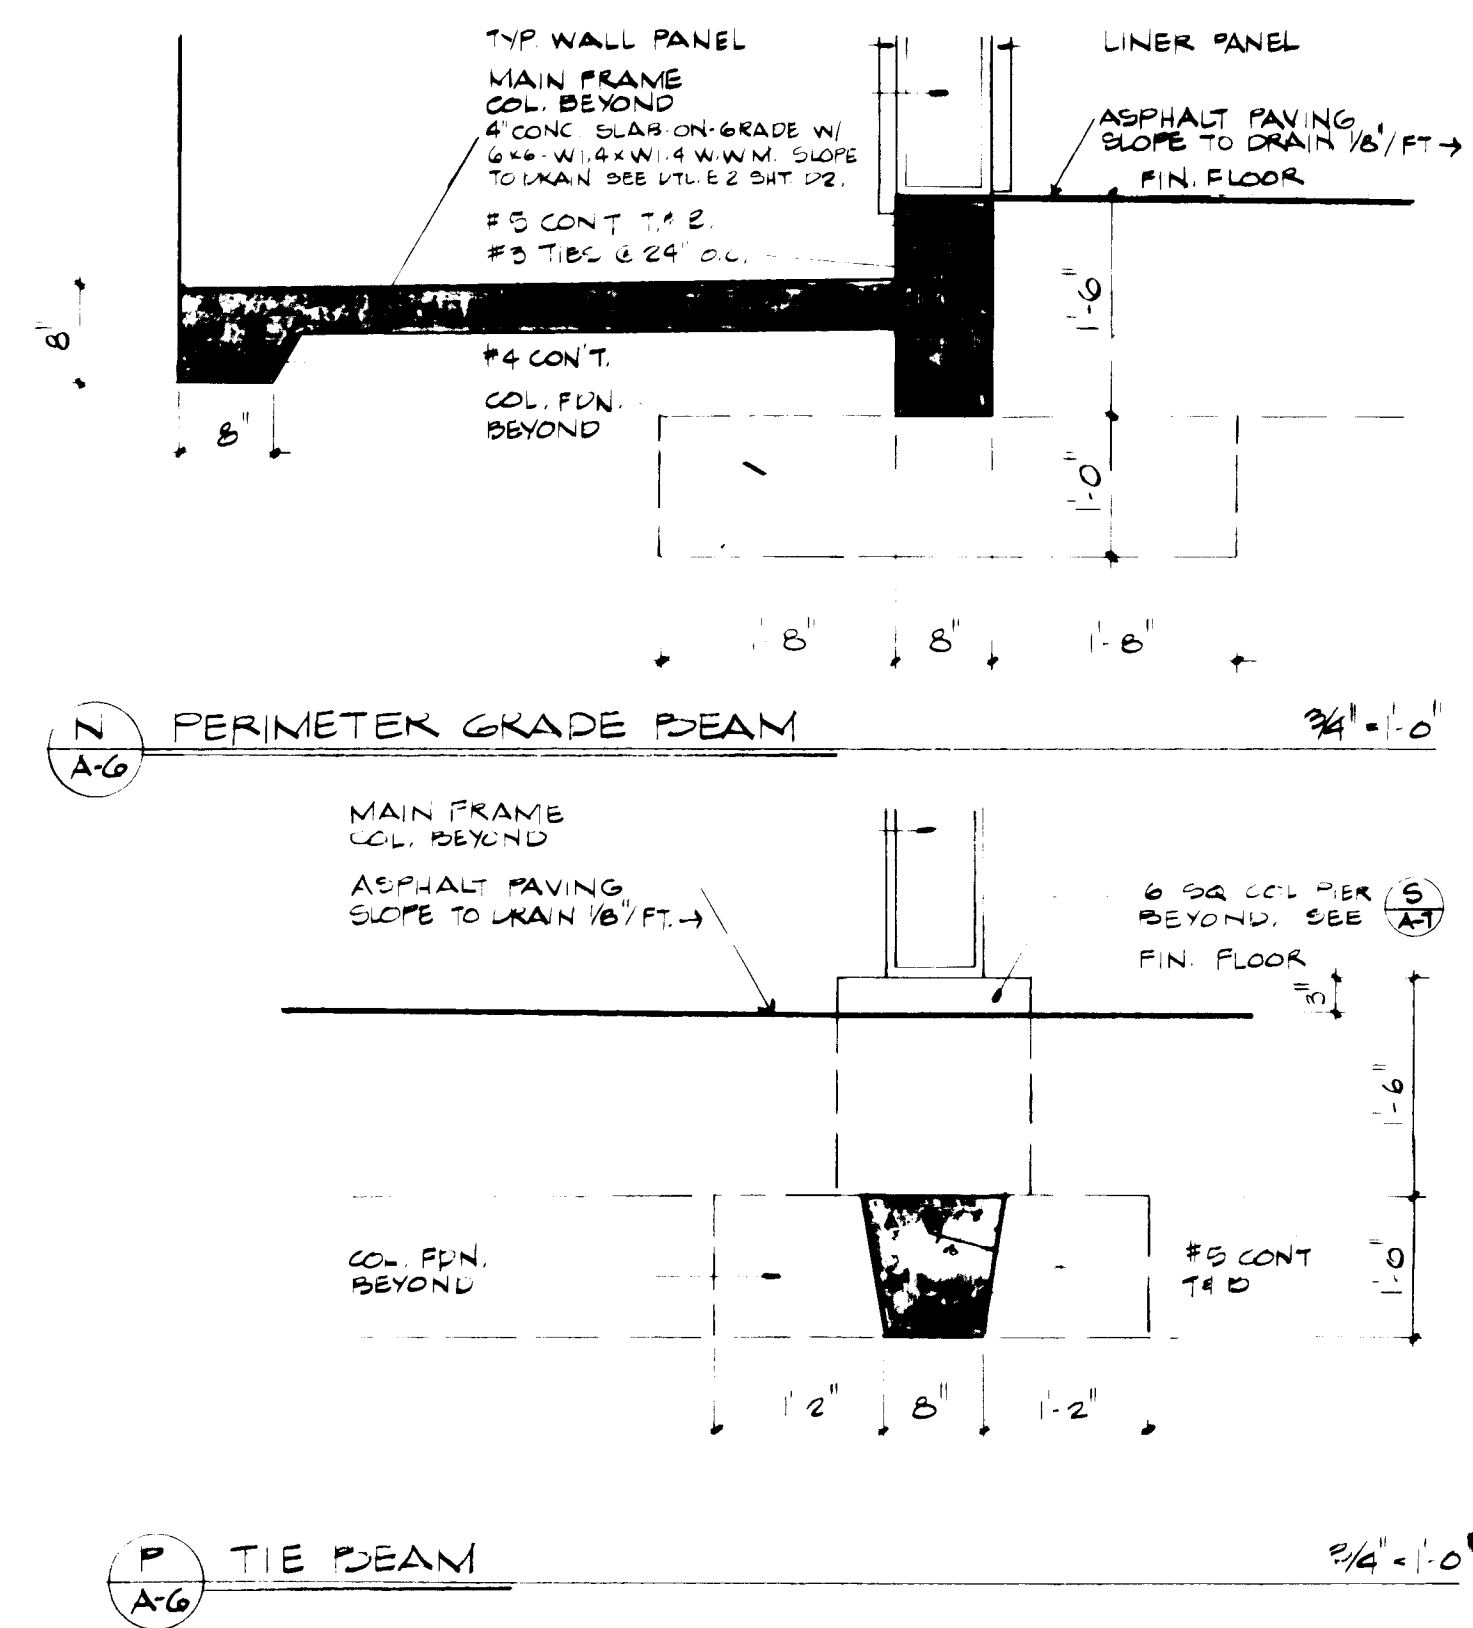


ONE-HOUR SEPARATION

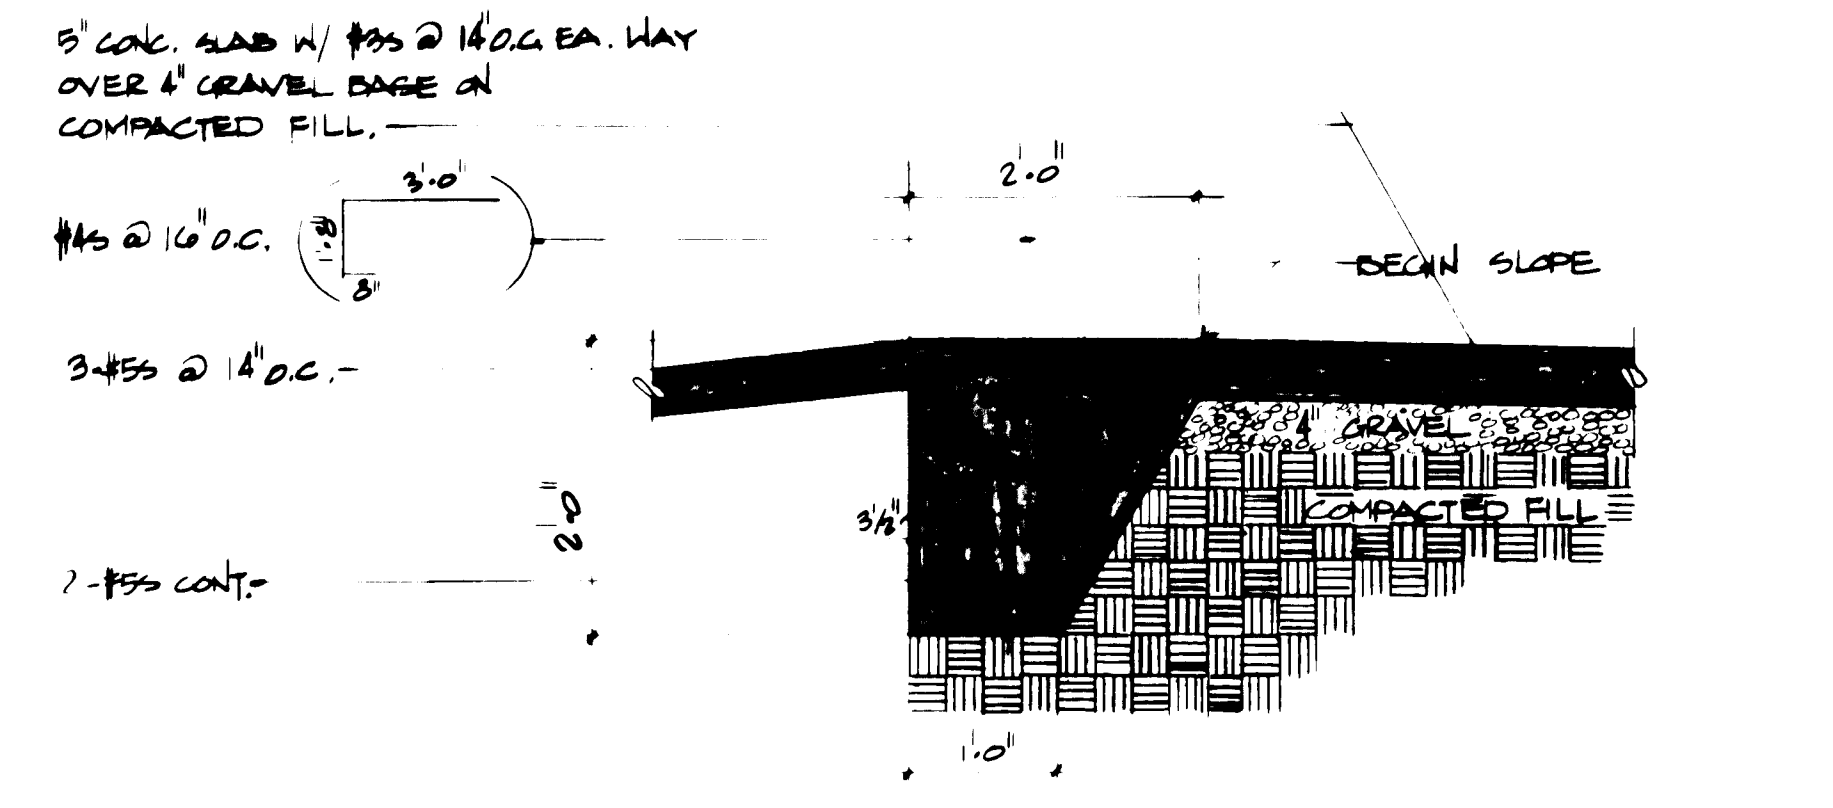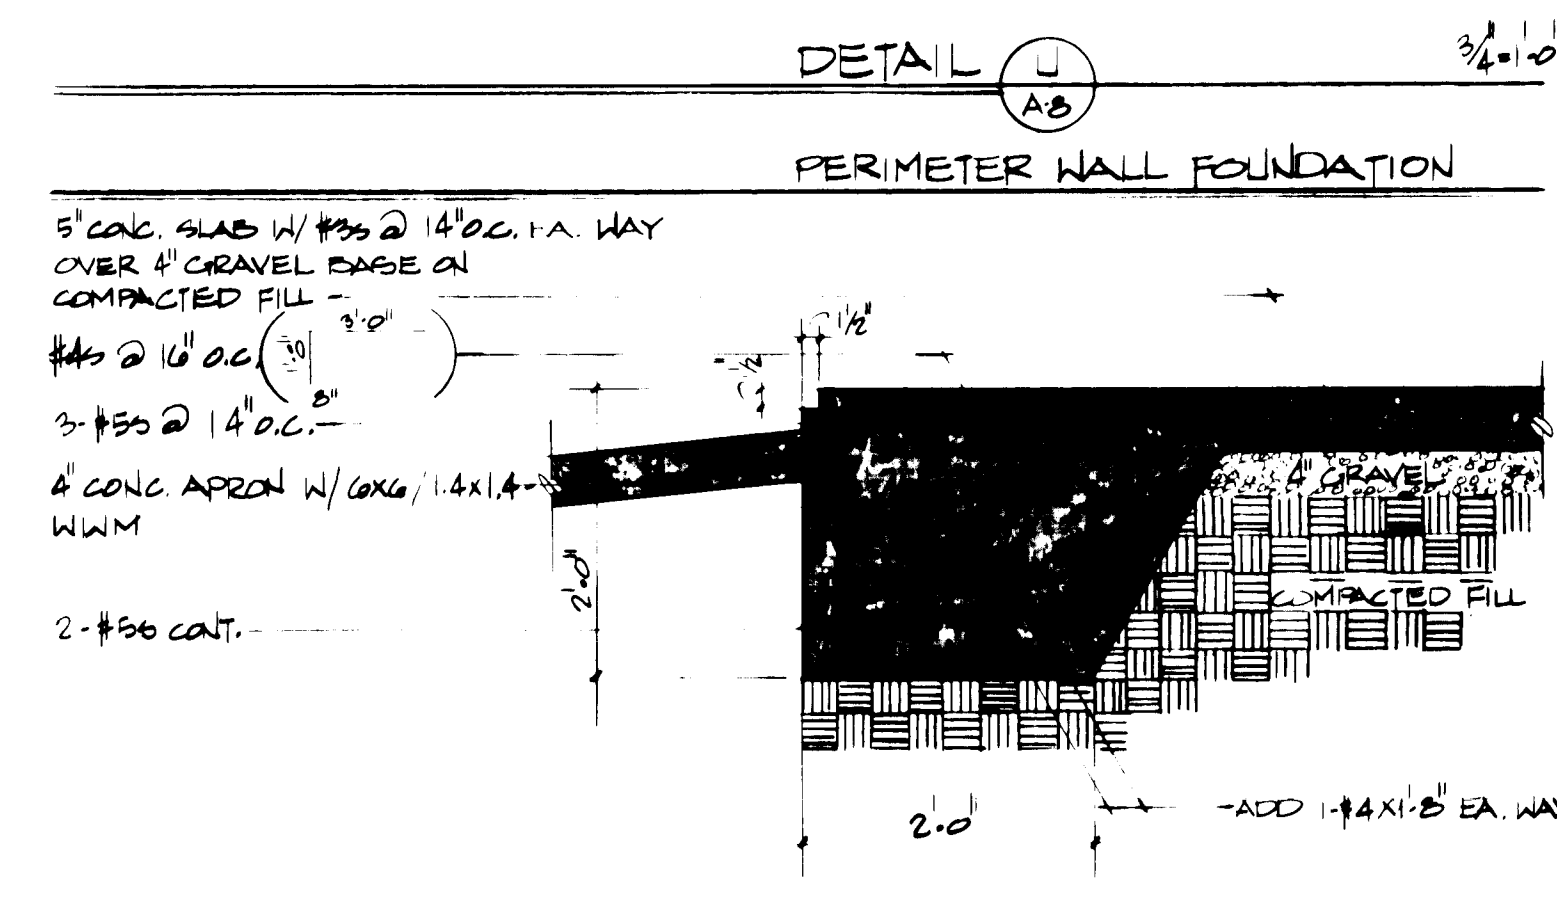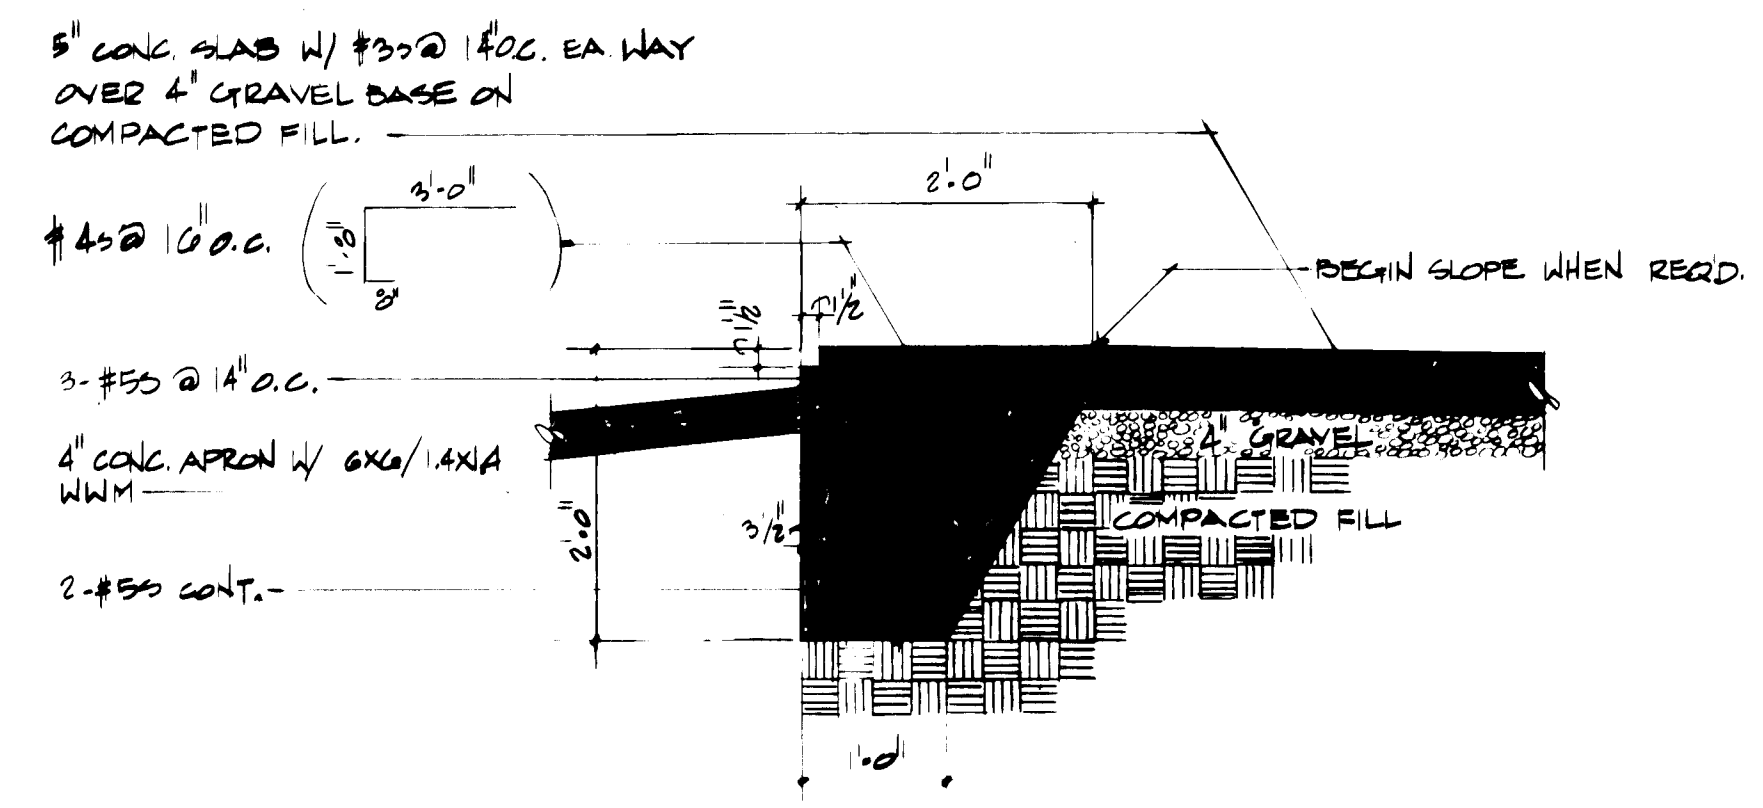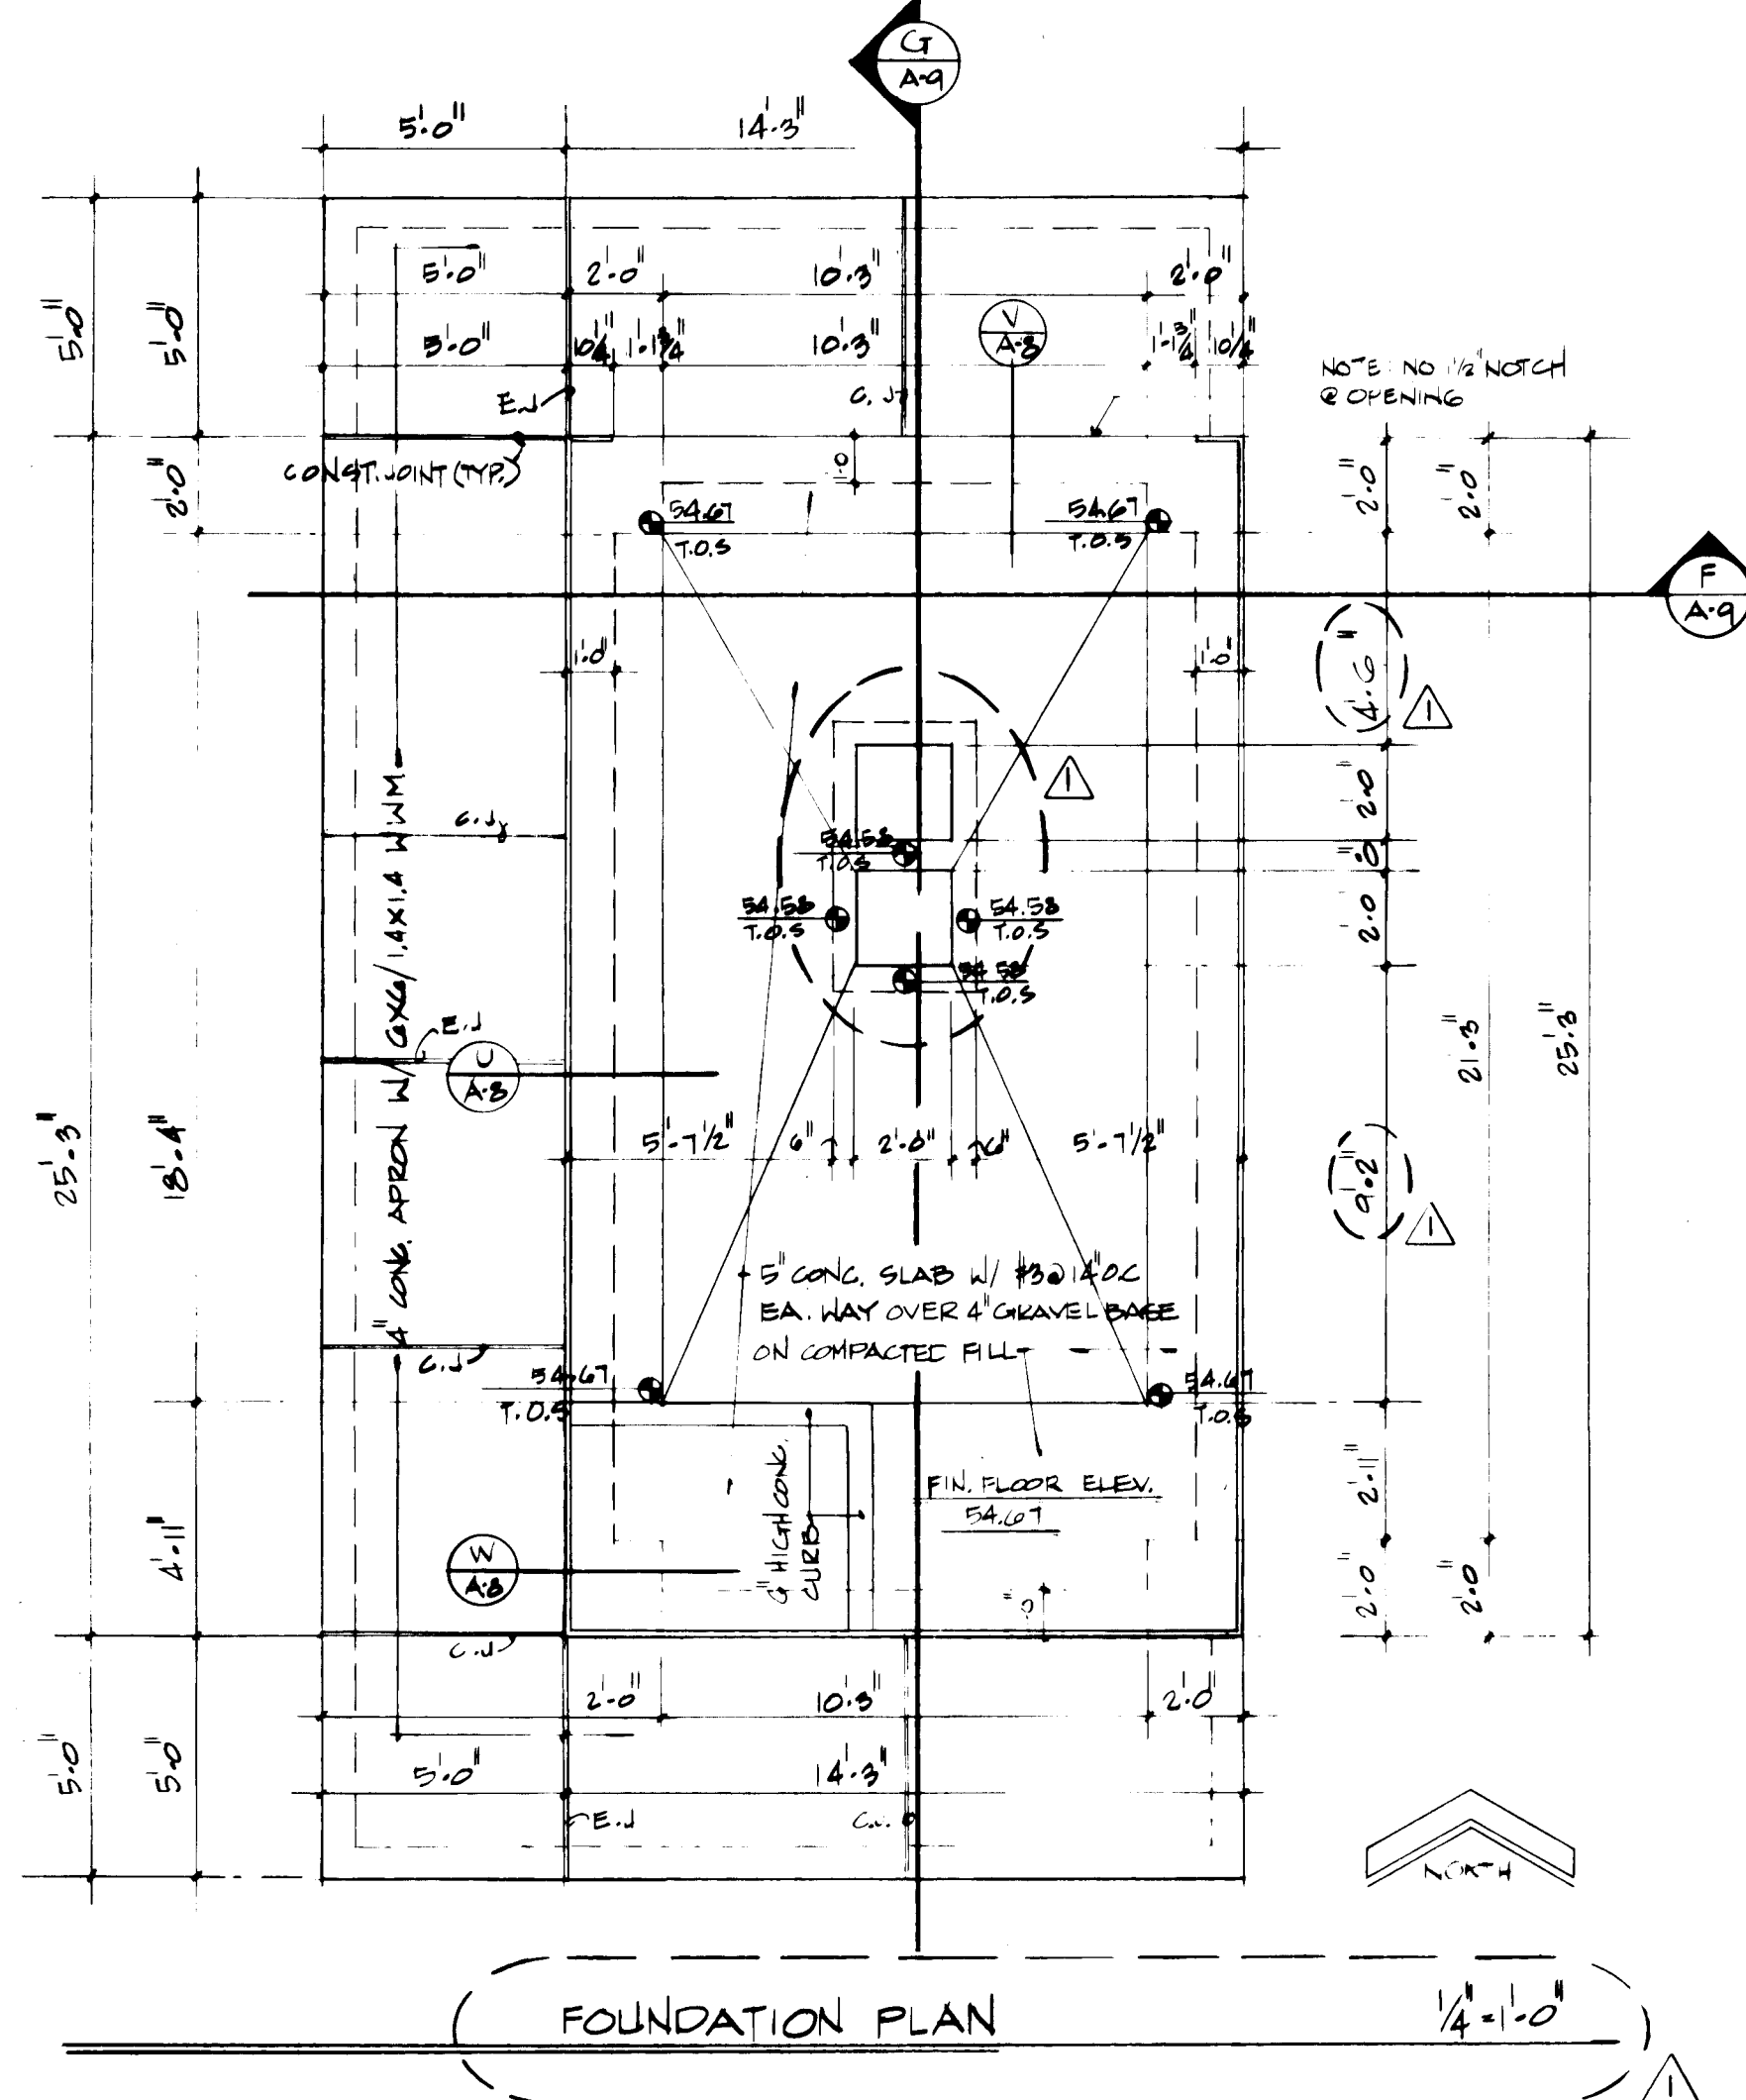

DOOR SCHEDULE

No.	SIZE	TYPE	WARE	FRAME	THRESHOLD	REMARKS
17	2'-0" X 6'-8" X 1 3/4"	A	T	H.M.	•	INSULATED
18	2'-0" X 7'-0" X 1 3/4"	A	T	H.M.	•	INSULATED

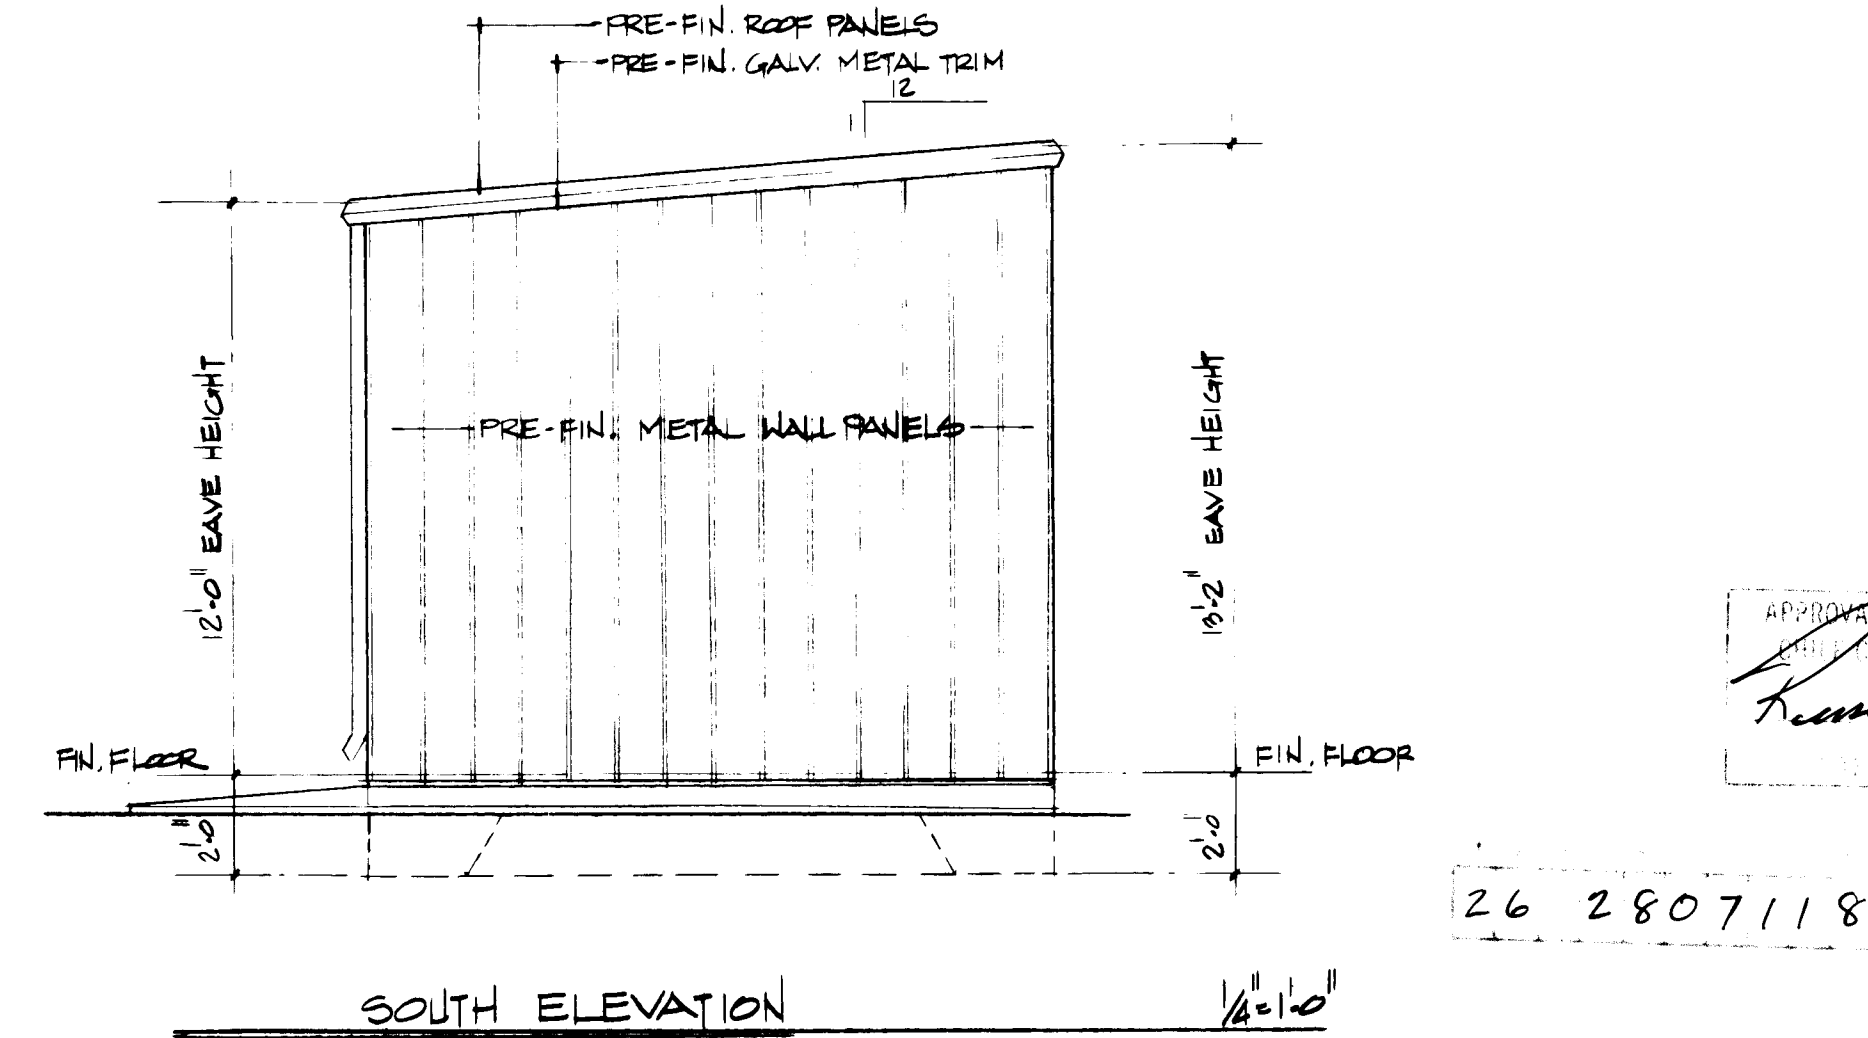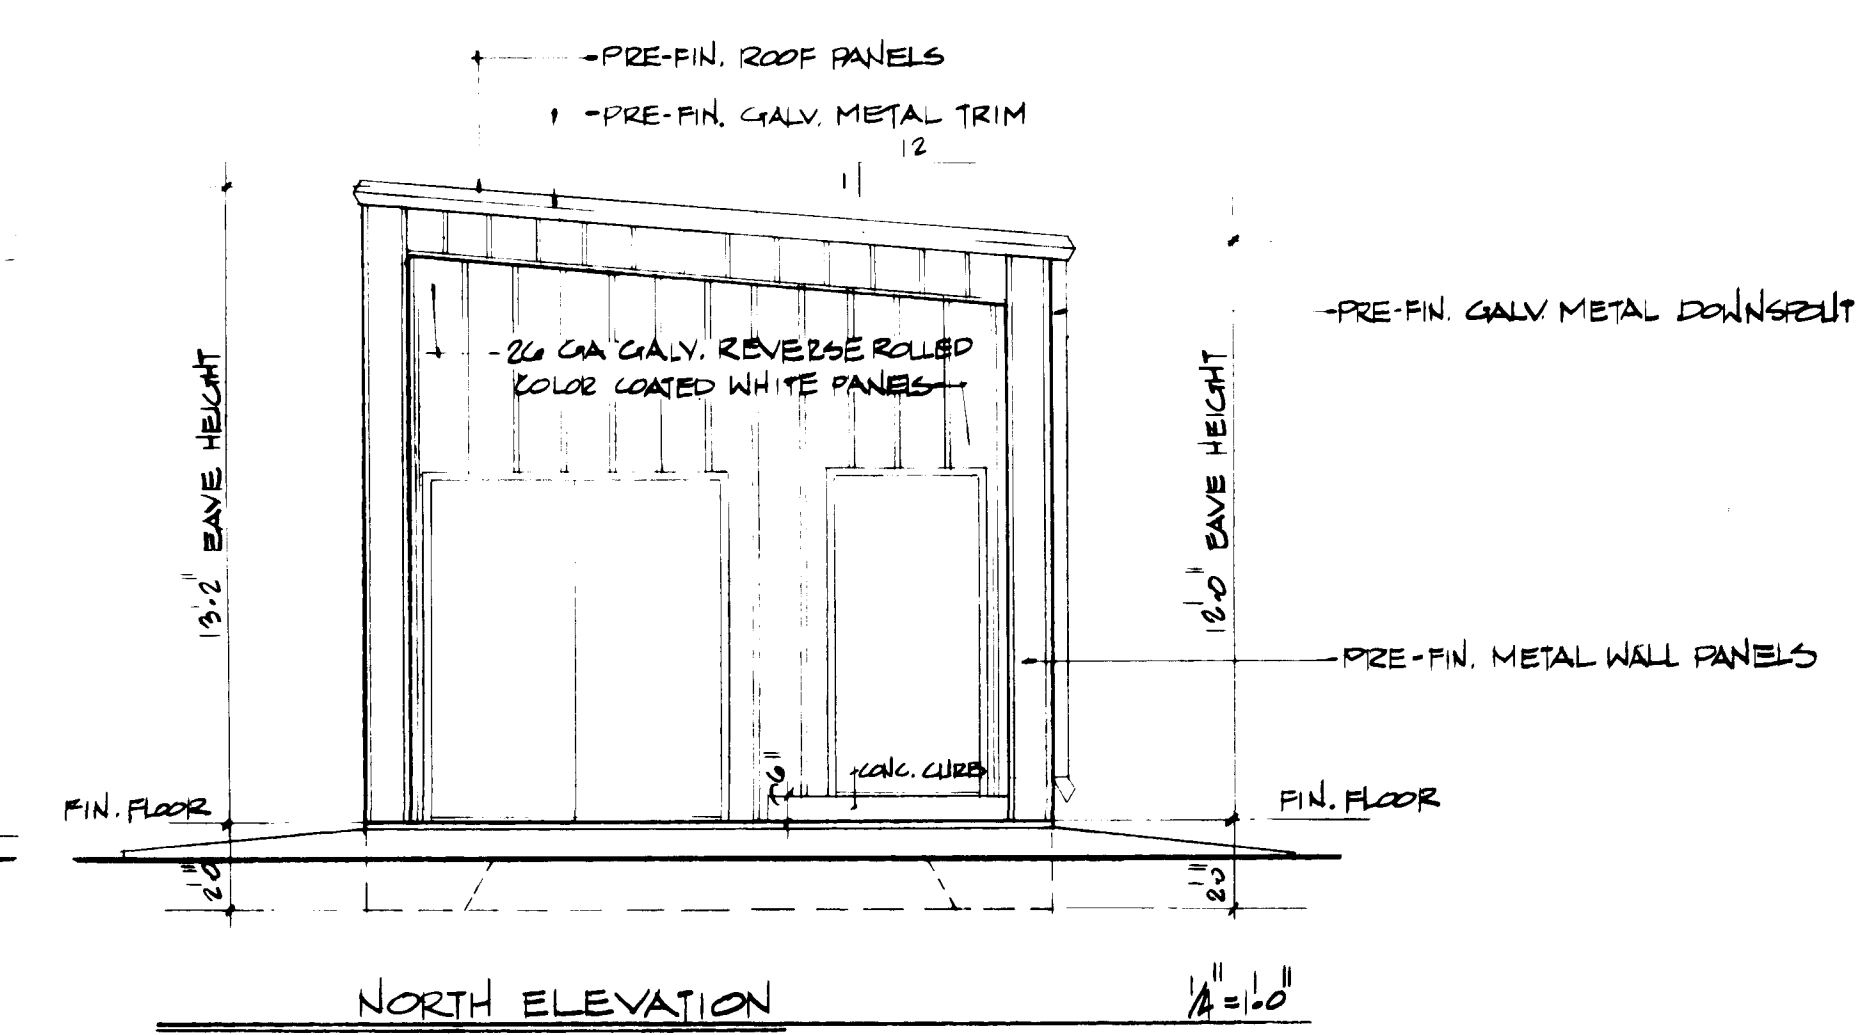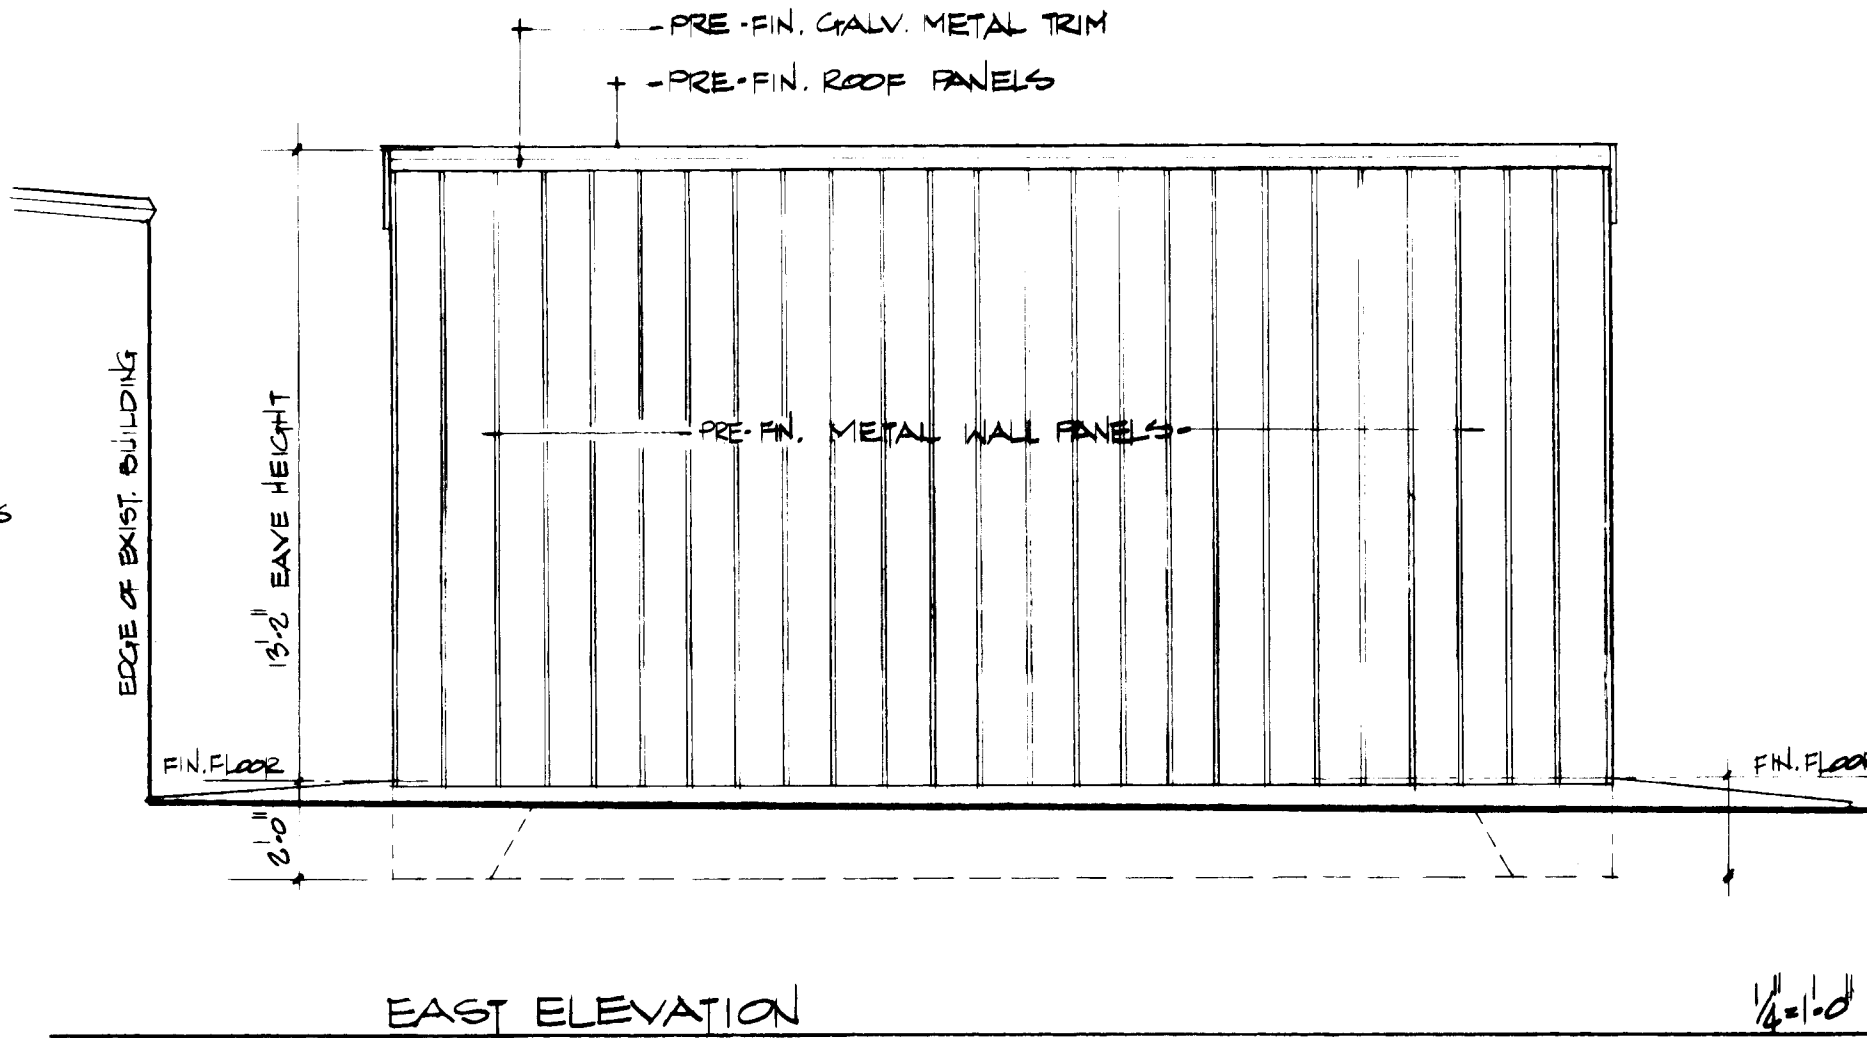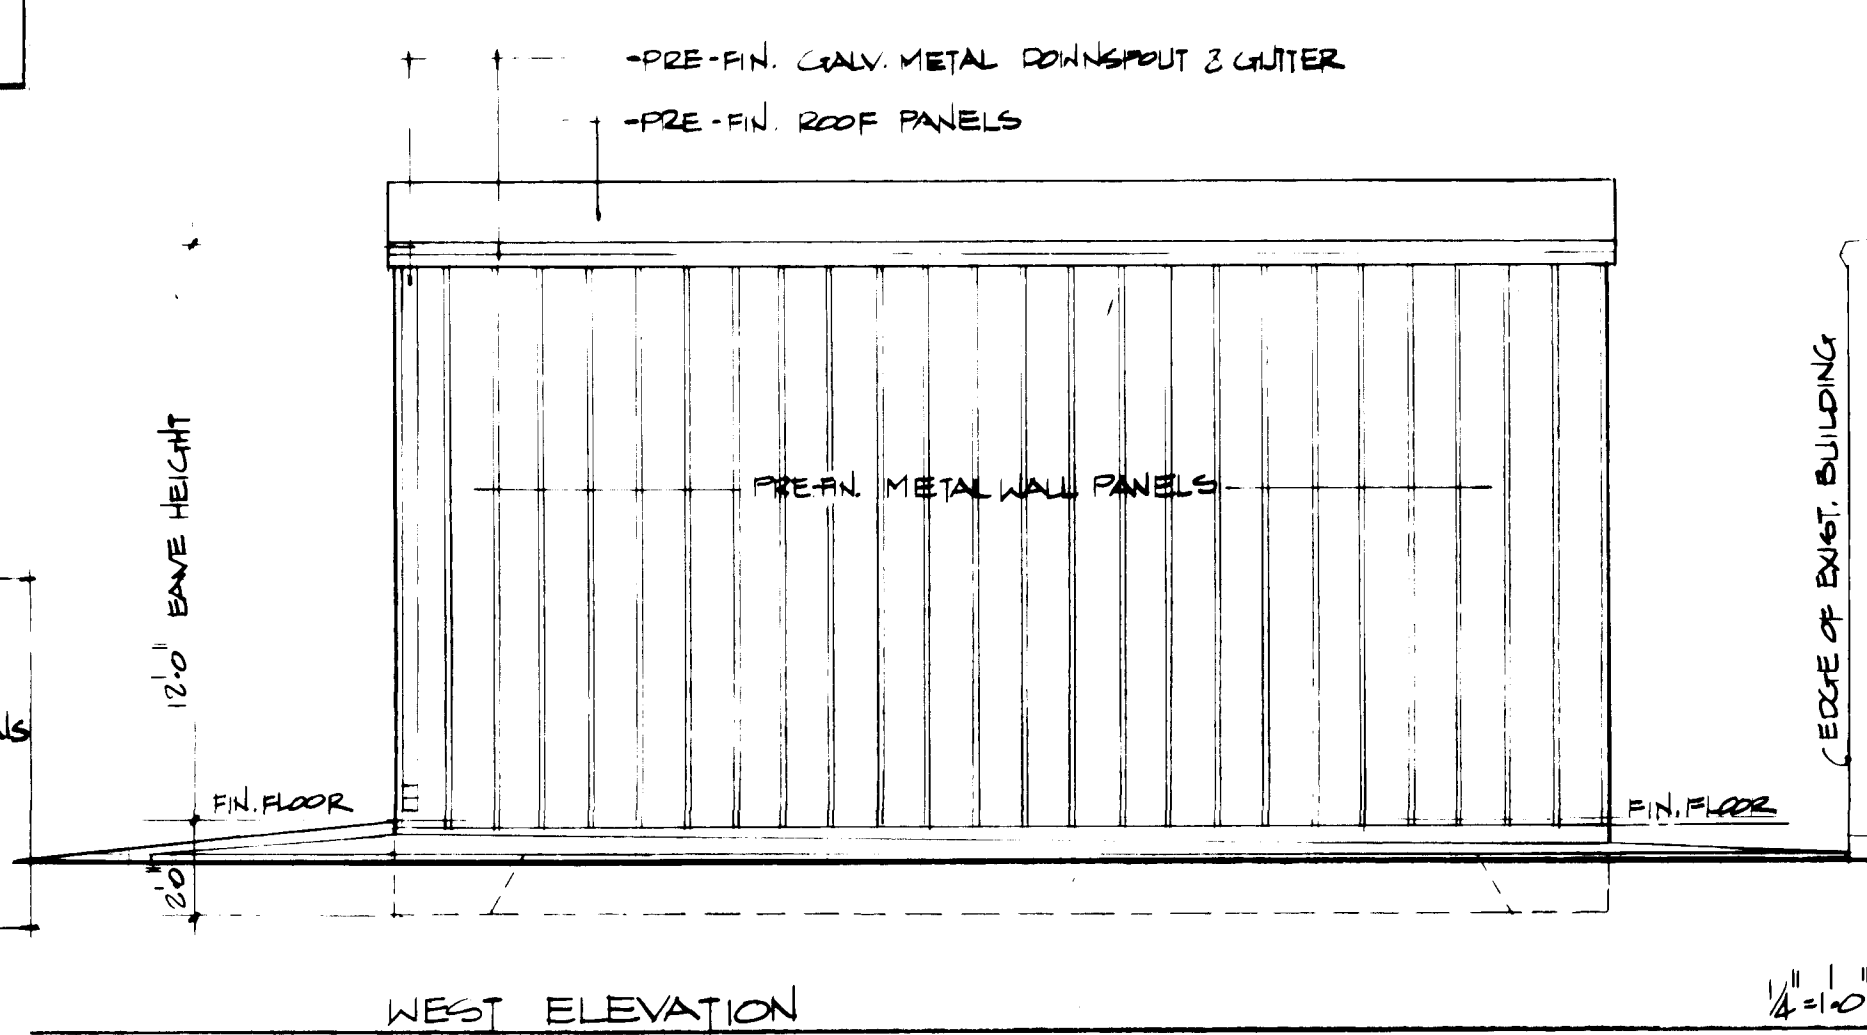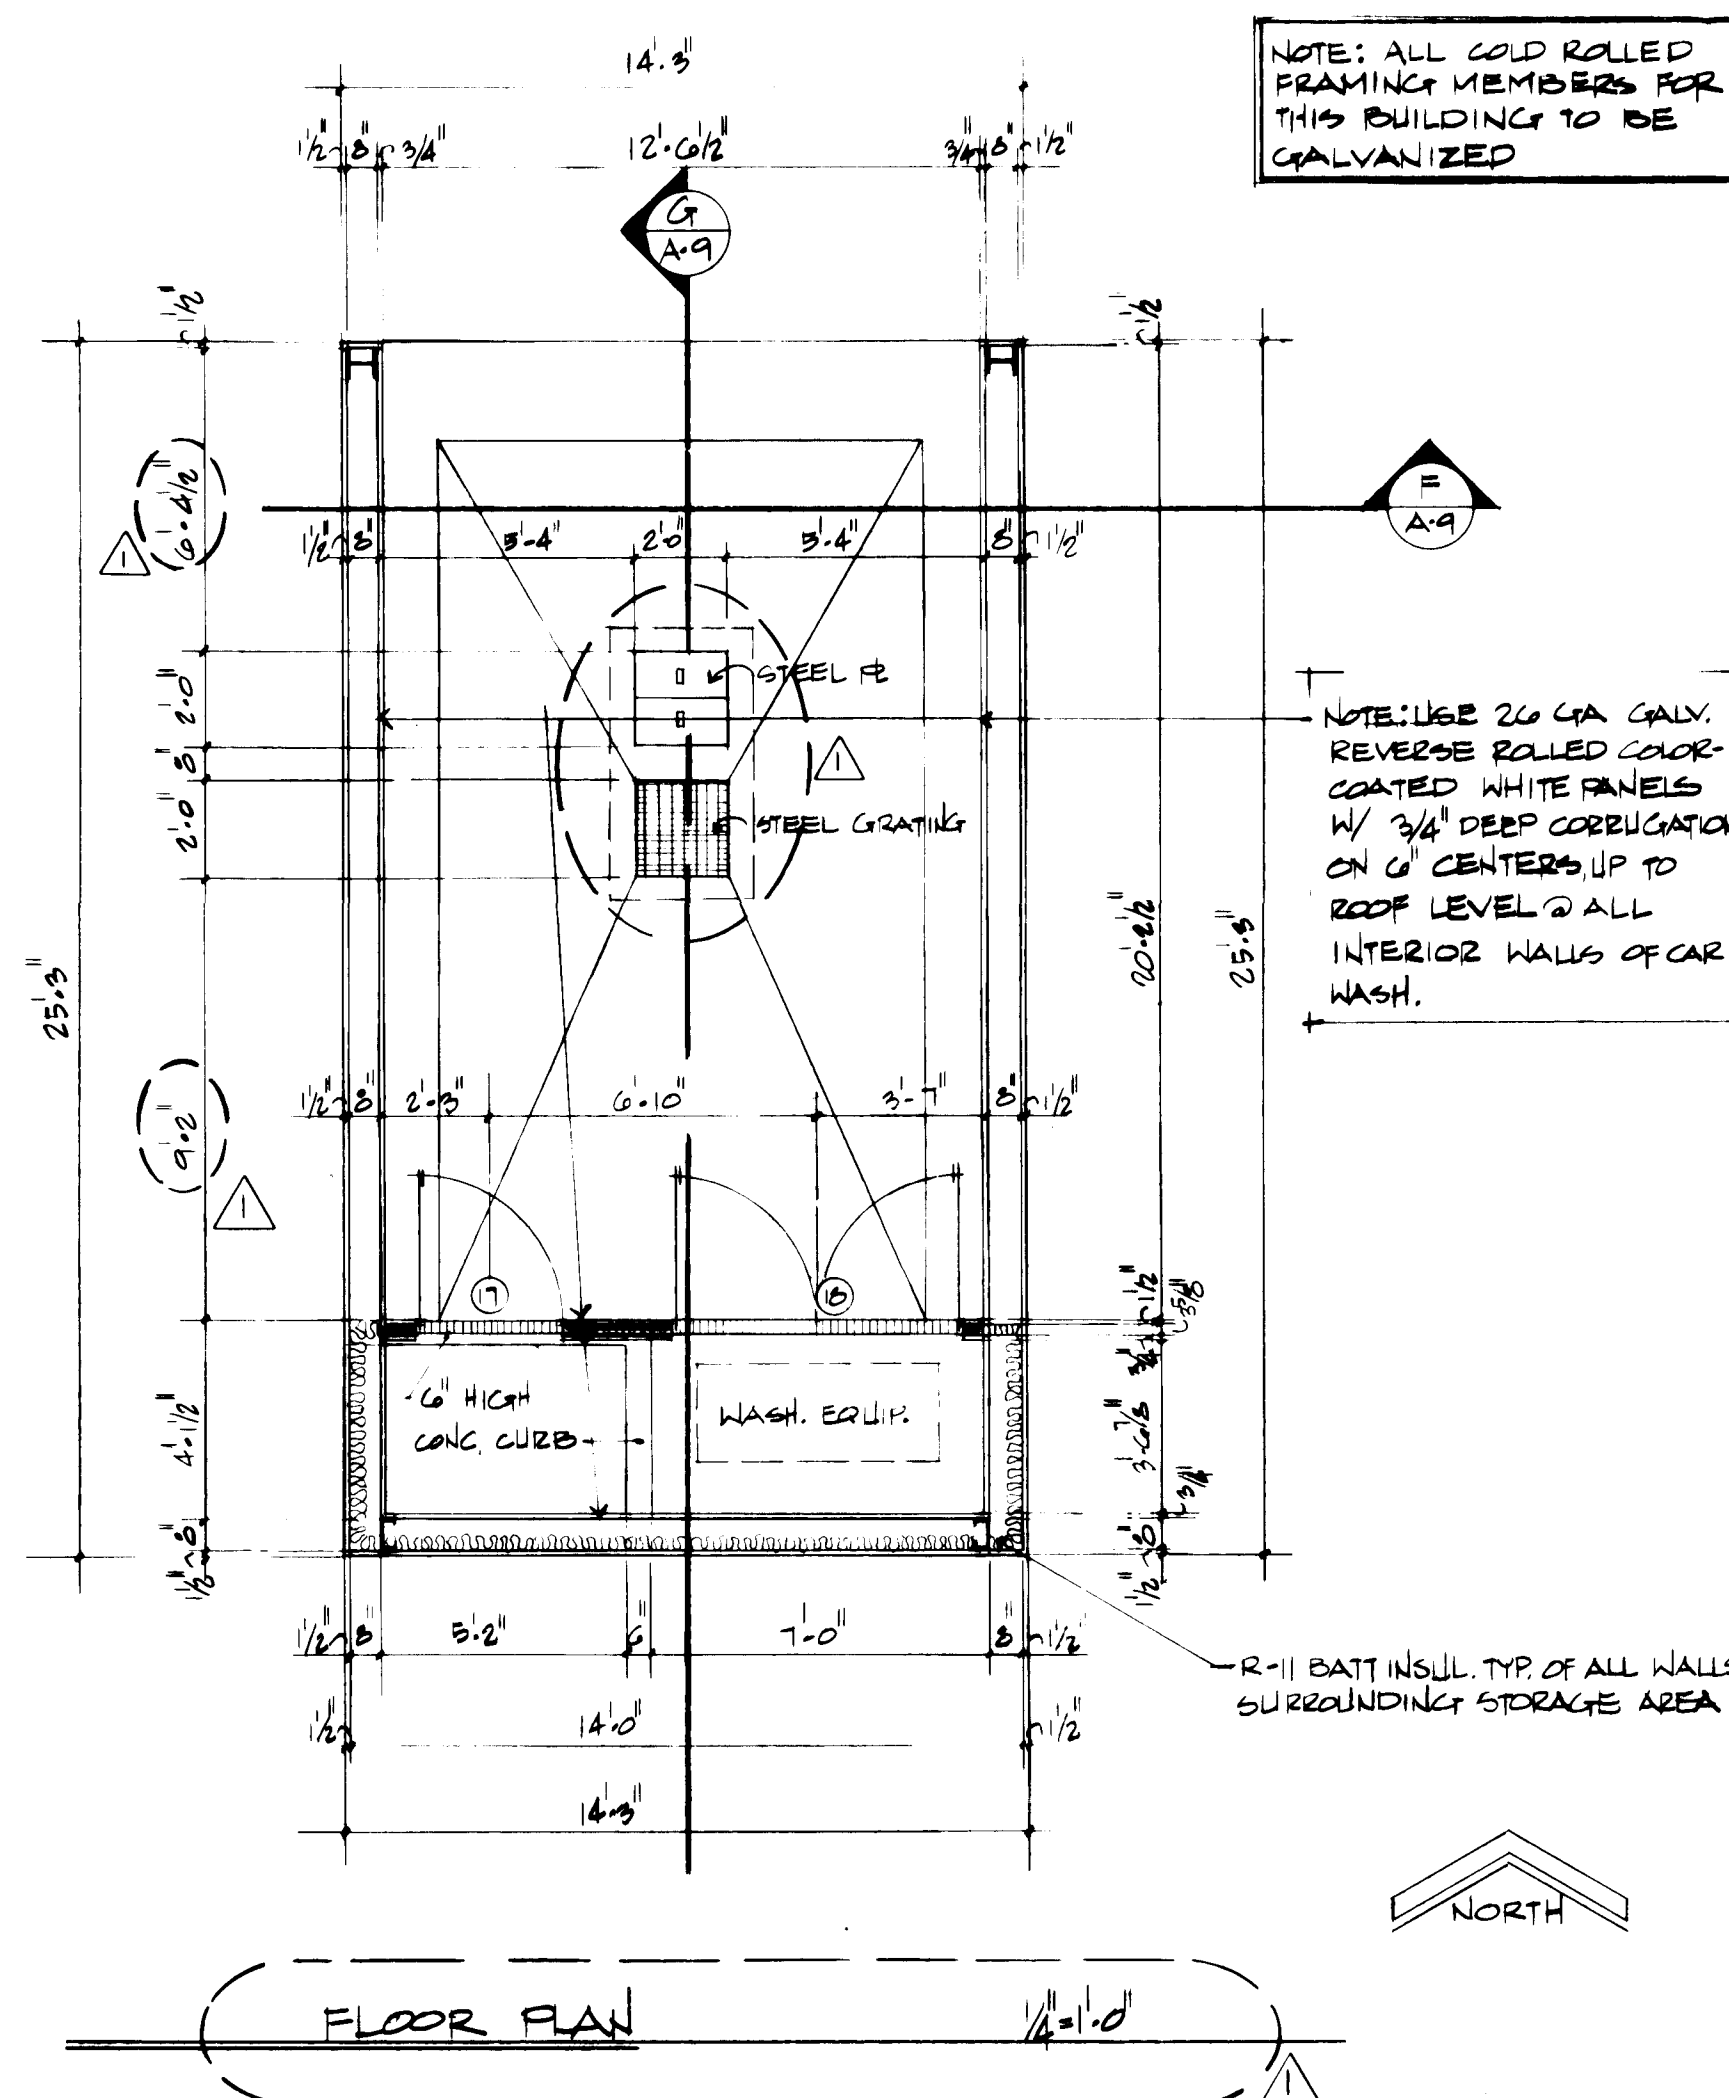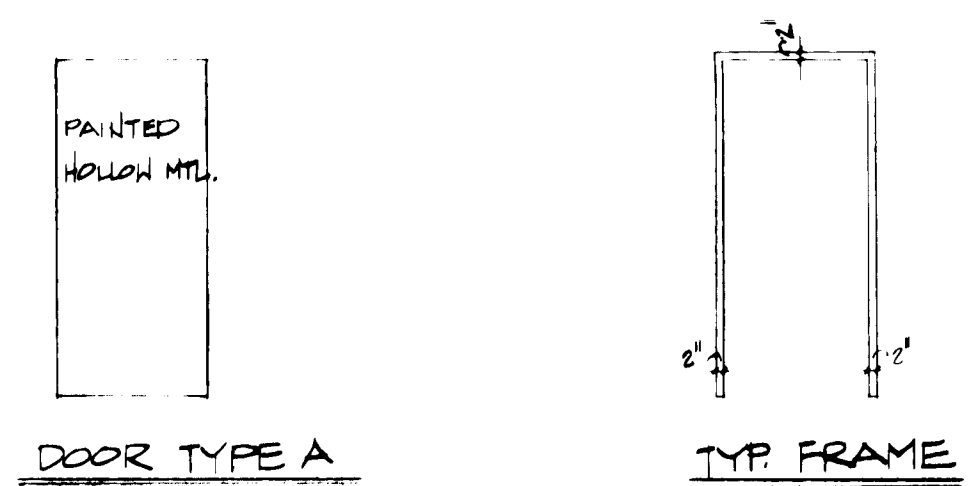

APPROVED BY
Russell B. Smith
1-12-88

26 28071188

$14 = 1.0$

 $\frac{1}{4} \text{ e}^- \cdot \text{O}^{\bullet}$


2.0' EAVE HT.

2.6 28071088


Russell B. Smith
1-19-68

$$1/2'' = 1' - 0$$
$$1/4'' = 1-0$$


R EAST END WALL COL. FDN. $3/4" = 1'-0"$
A-60

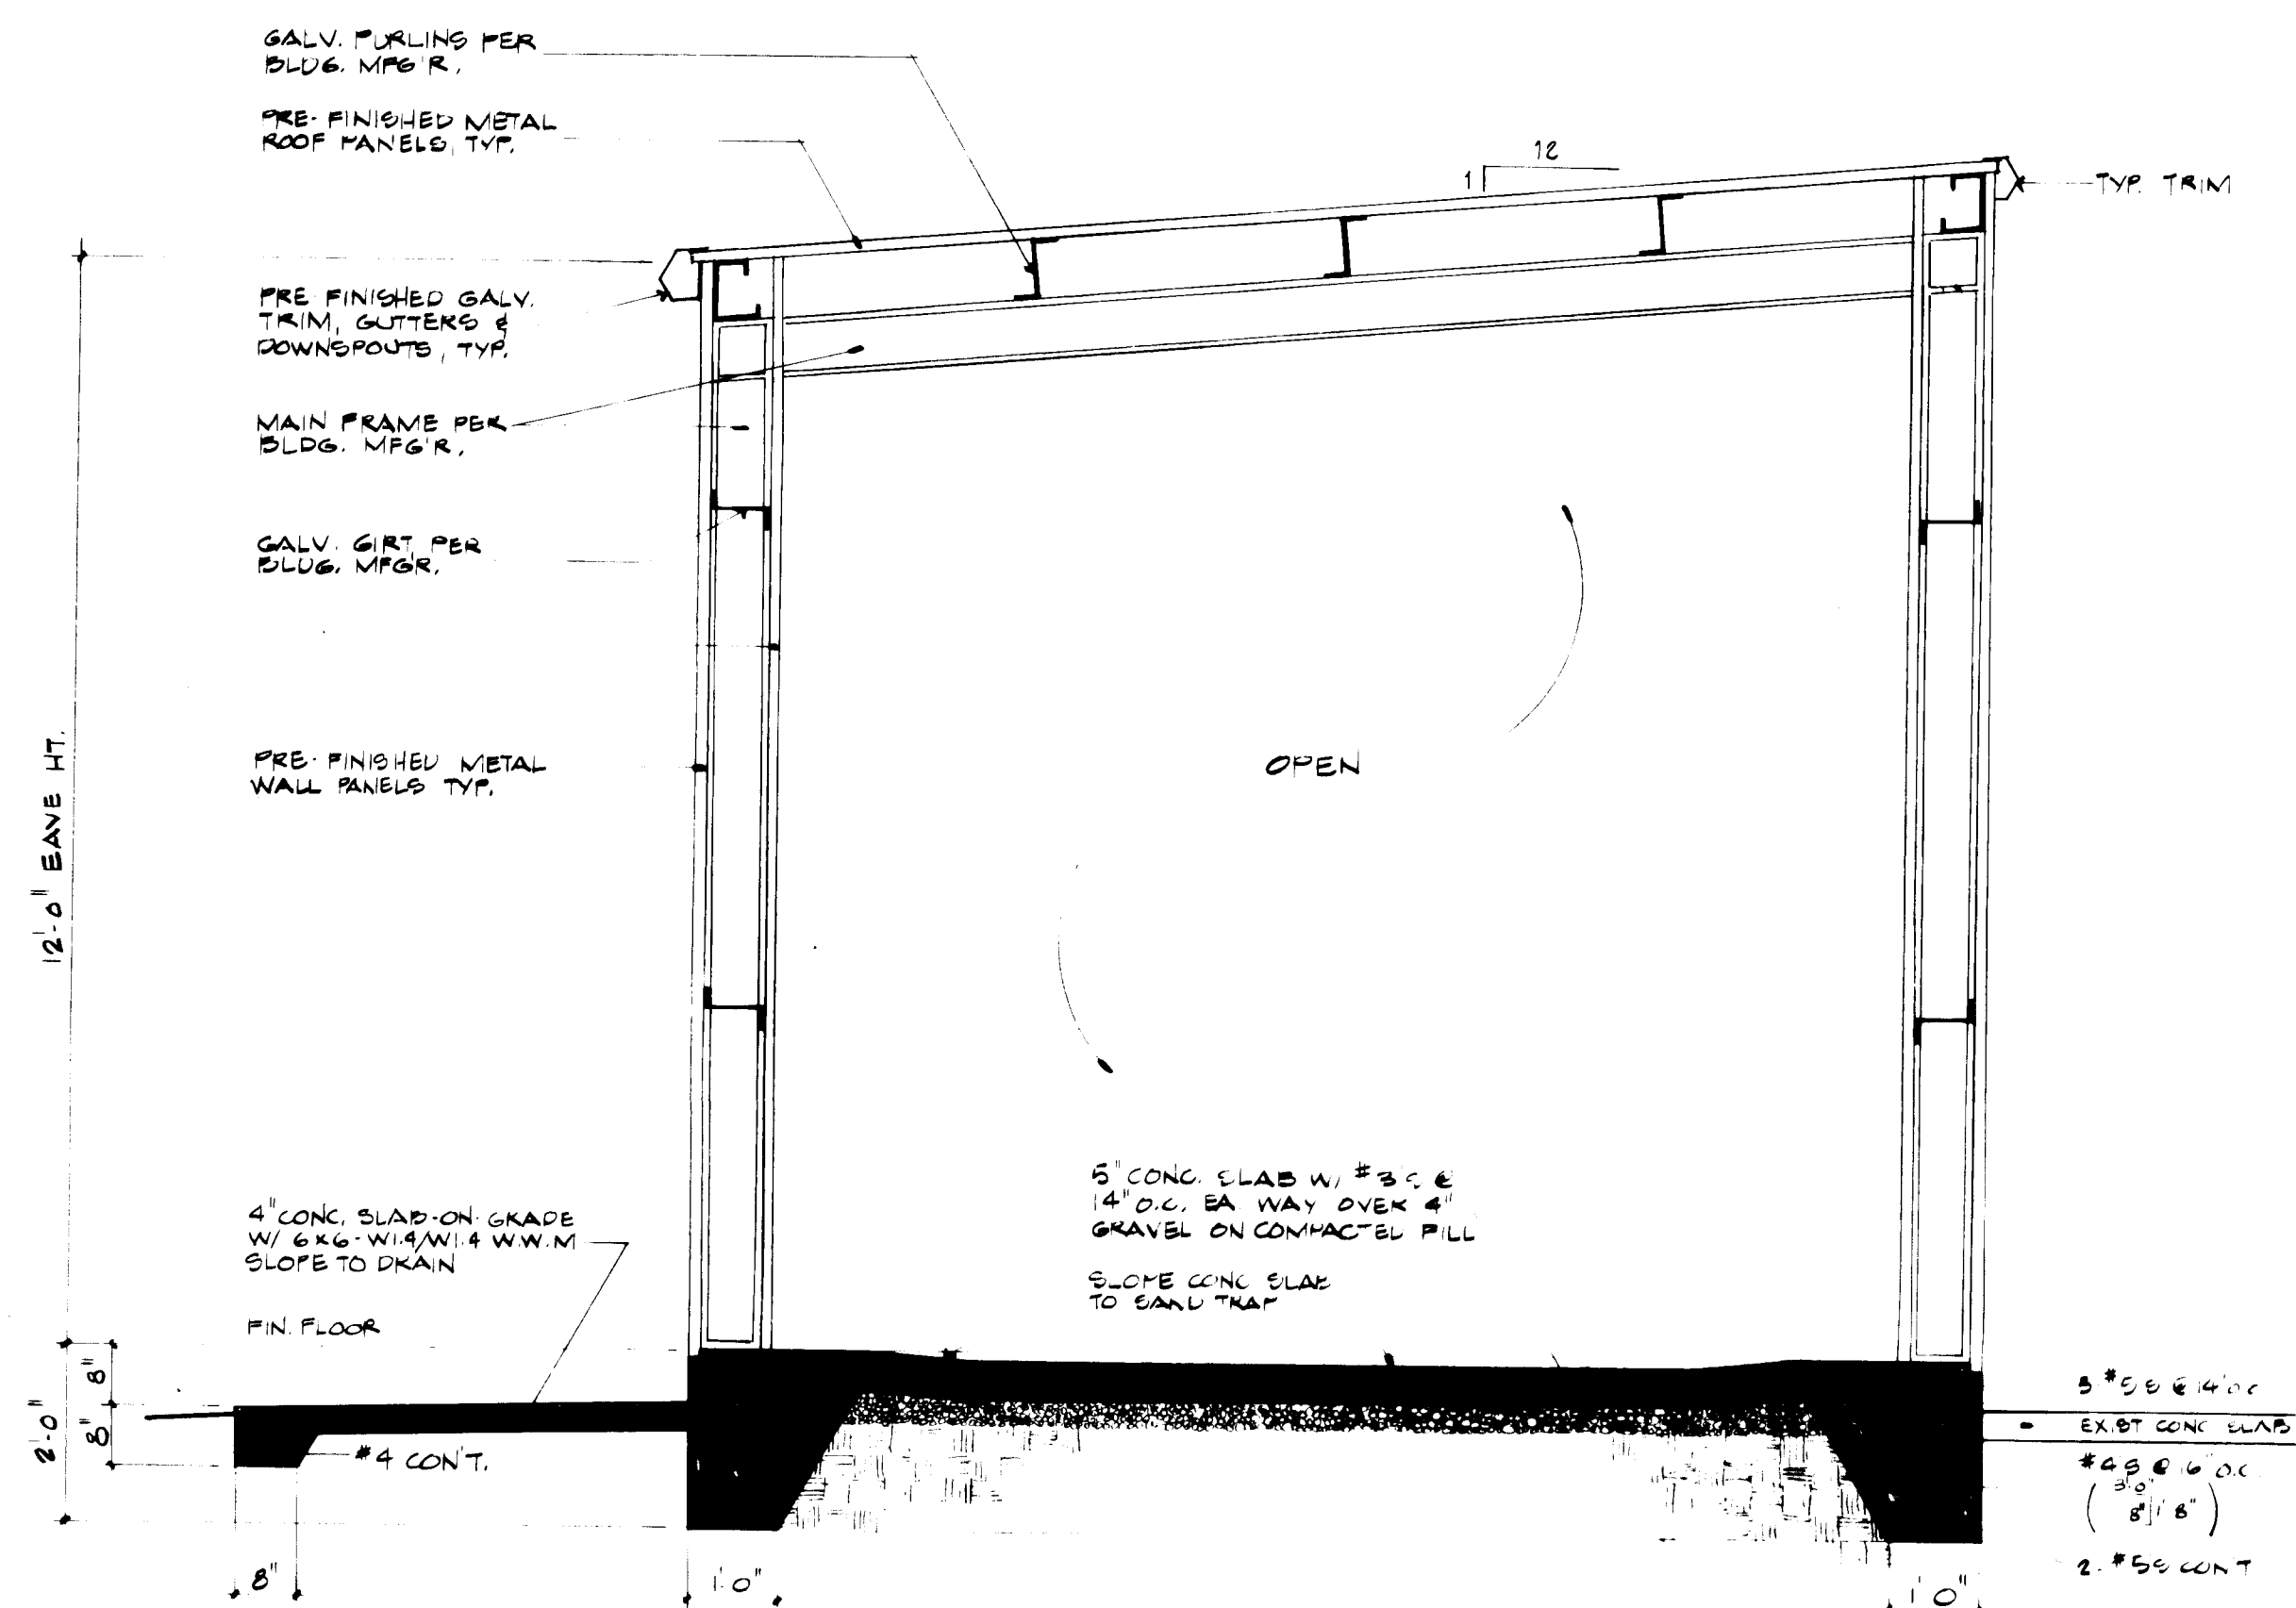

(X) SECTION 6 GLNITE RETENTION POND

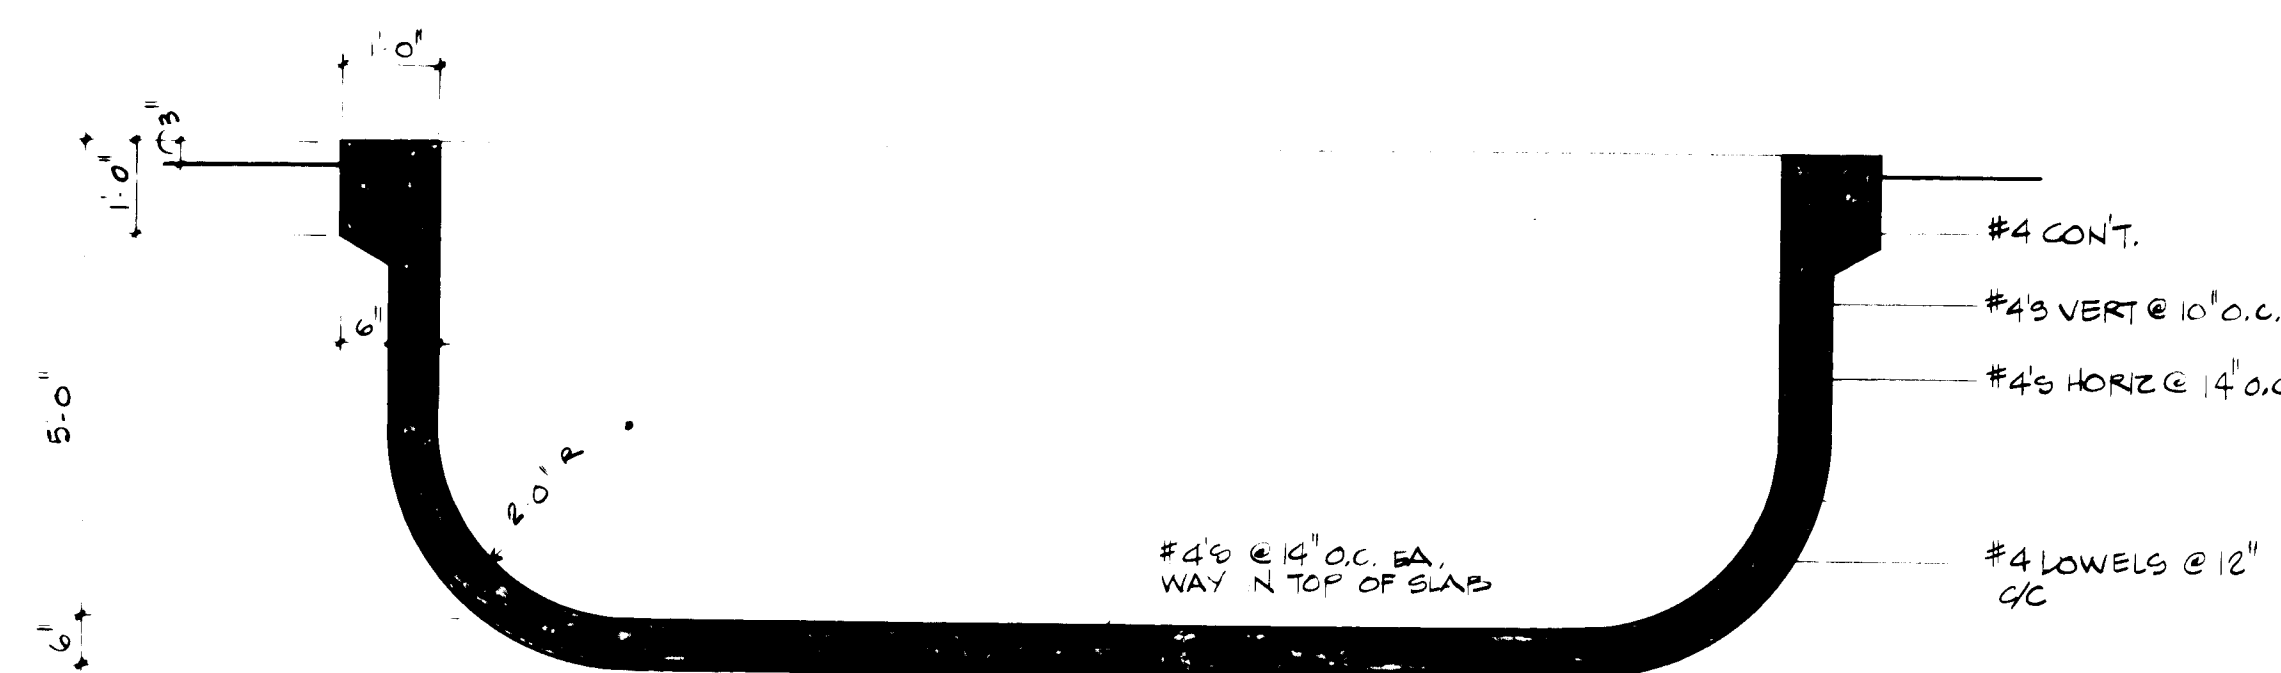

F BUILDING SECTION - CAR WASH

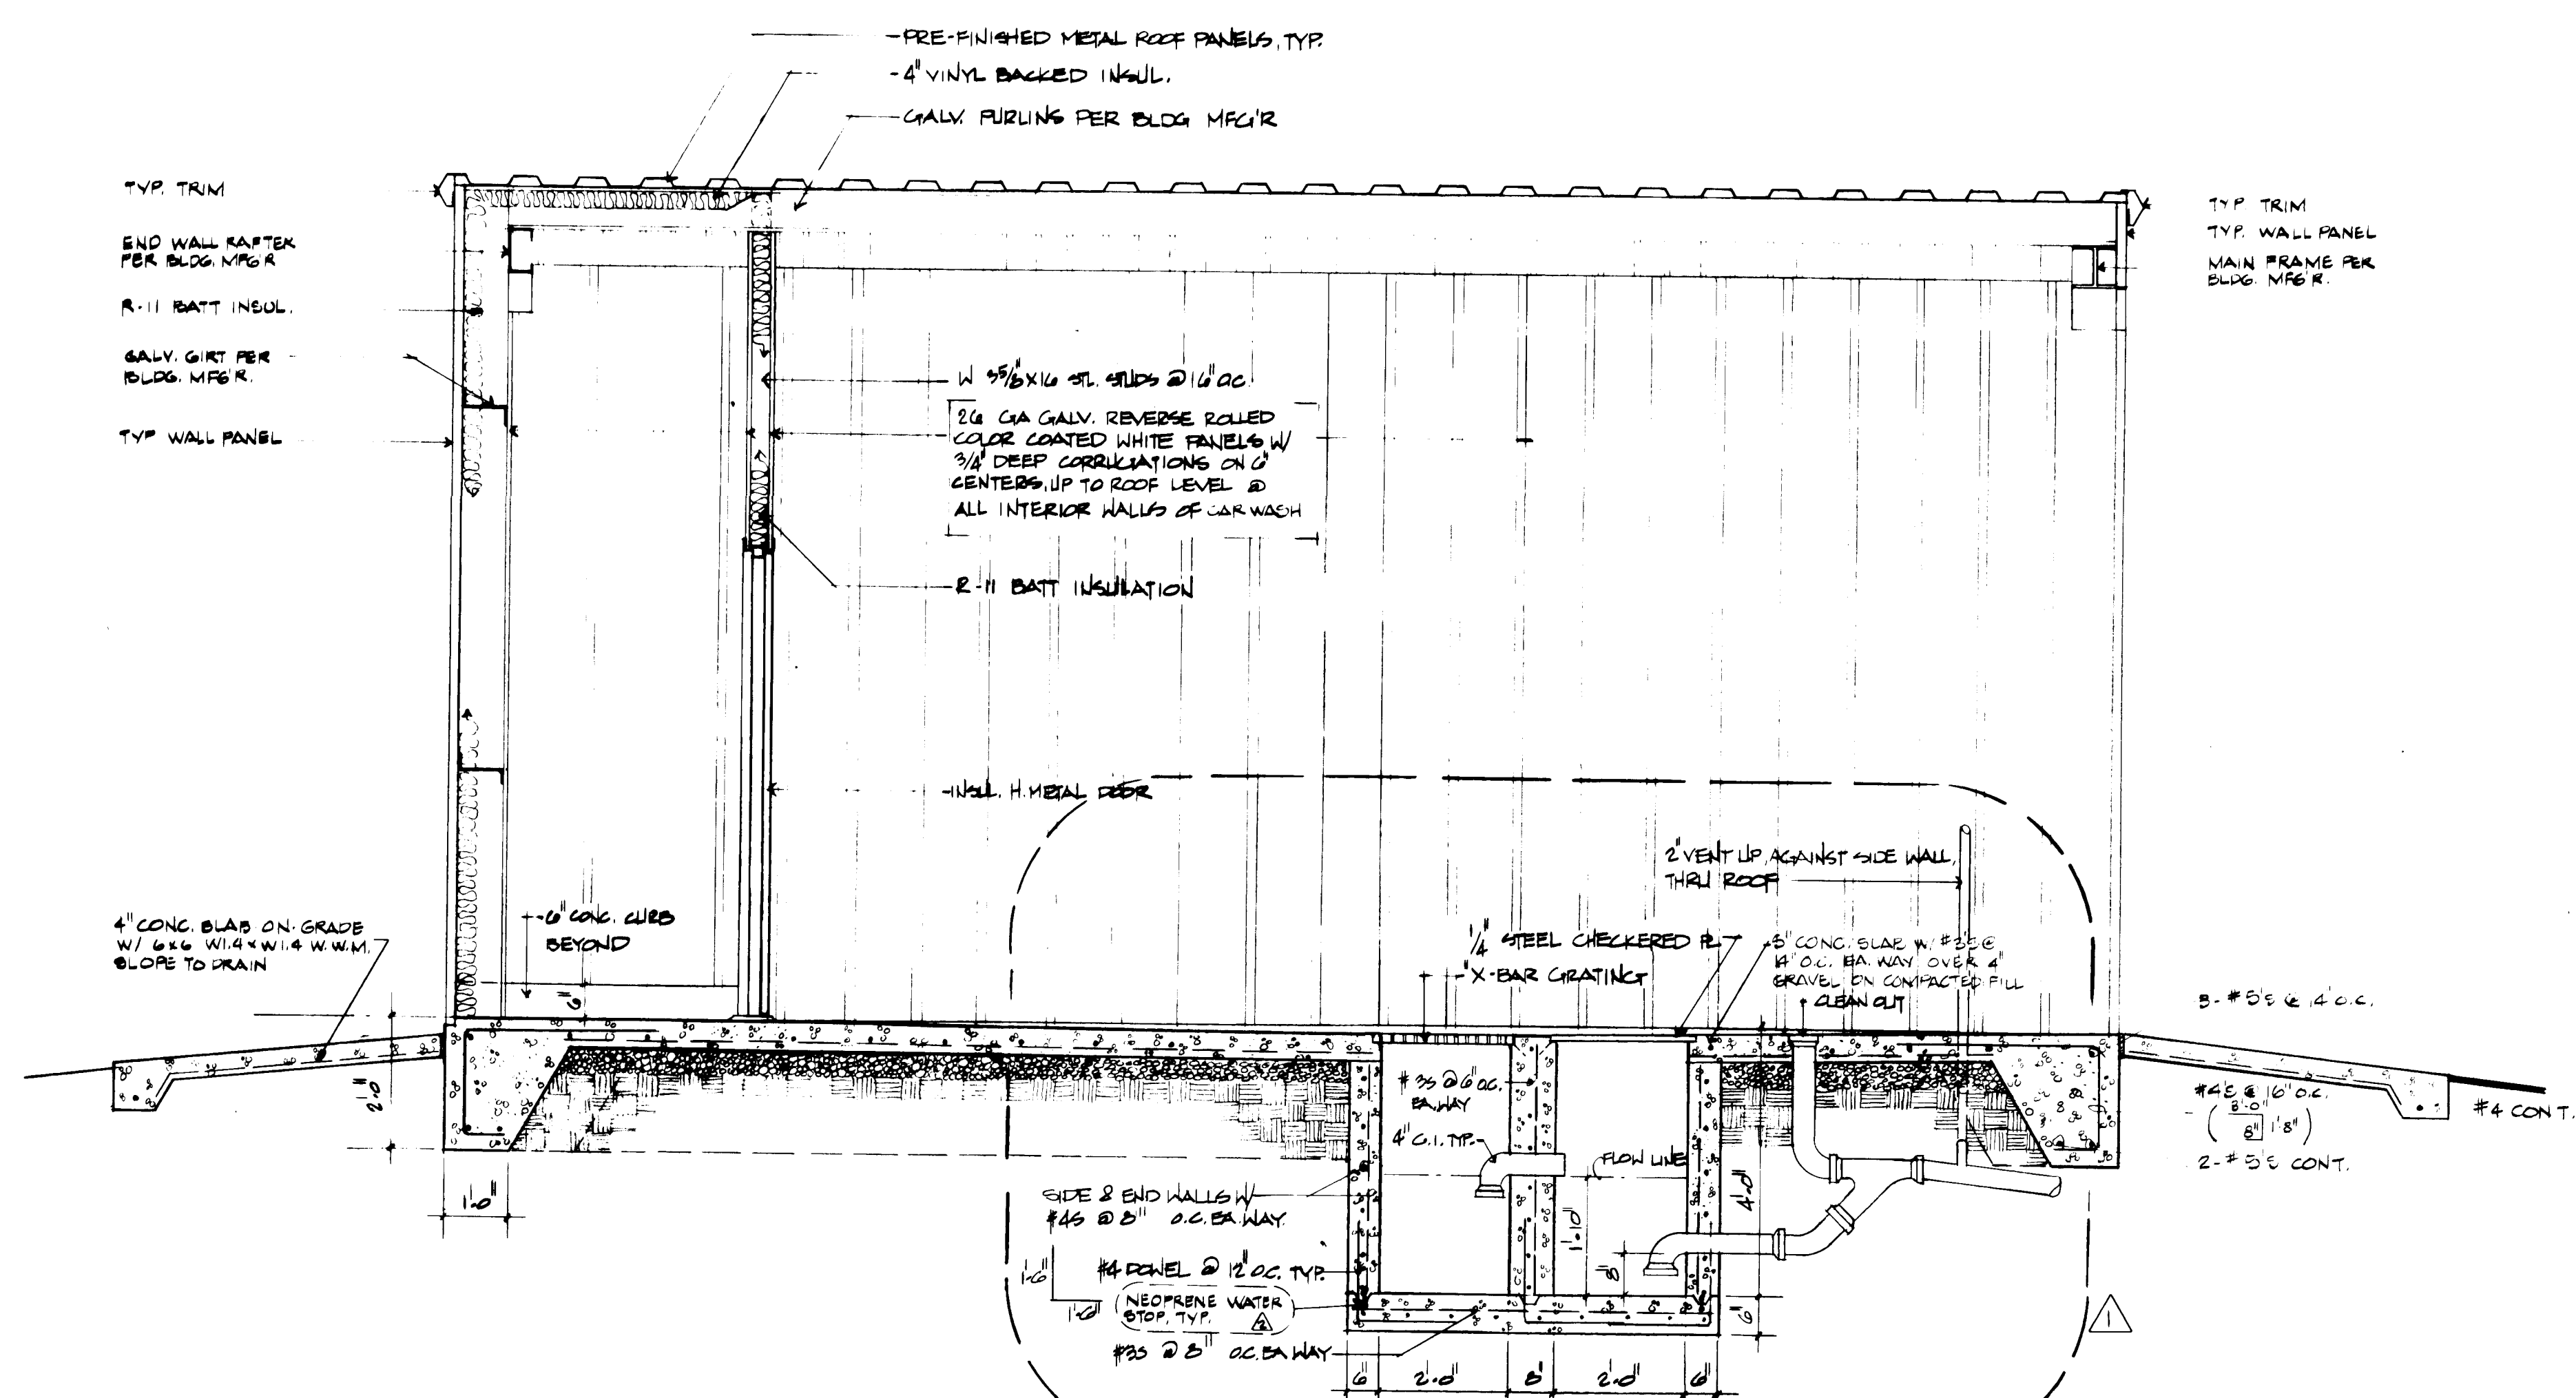

BUILDING SECTION - CAR WASH

RECORD DRAWING

CAR WASH
SECTIONS F & G
GUNNITE RETENTION POND

MONTESSA PARK RENOVATION
FOR THE
CITY OF ALBUQUERQUE
ENVIRONMENTAL HEALTH DEPARTMENT

METRON ARCHITECTS GROUP
413 Montclair Drive NE
Atlanta, GA 30316



DATE: 10-15-86
REV: 8-15-86
△ SAND TRAP REVISED

PROJECT NUMBER 2807

SUBJECT 11-2-17

26 28071288

APPROVED BY ACTING CHIEF OF BUREAU
Russell B. Linder
 1-12-88

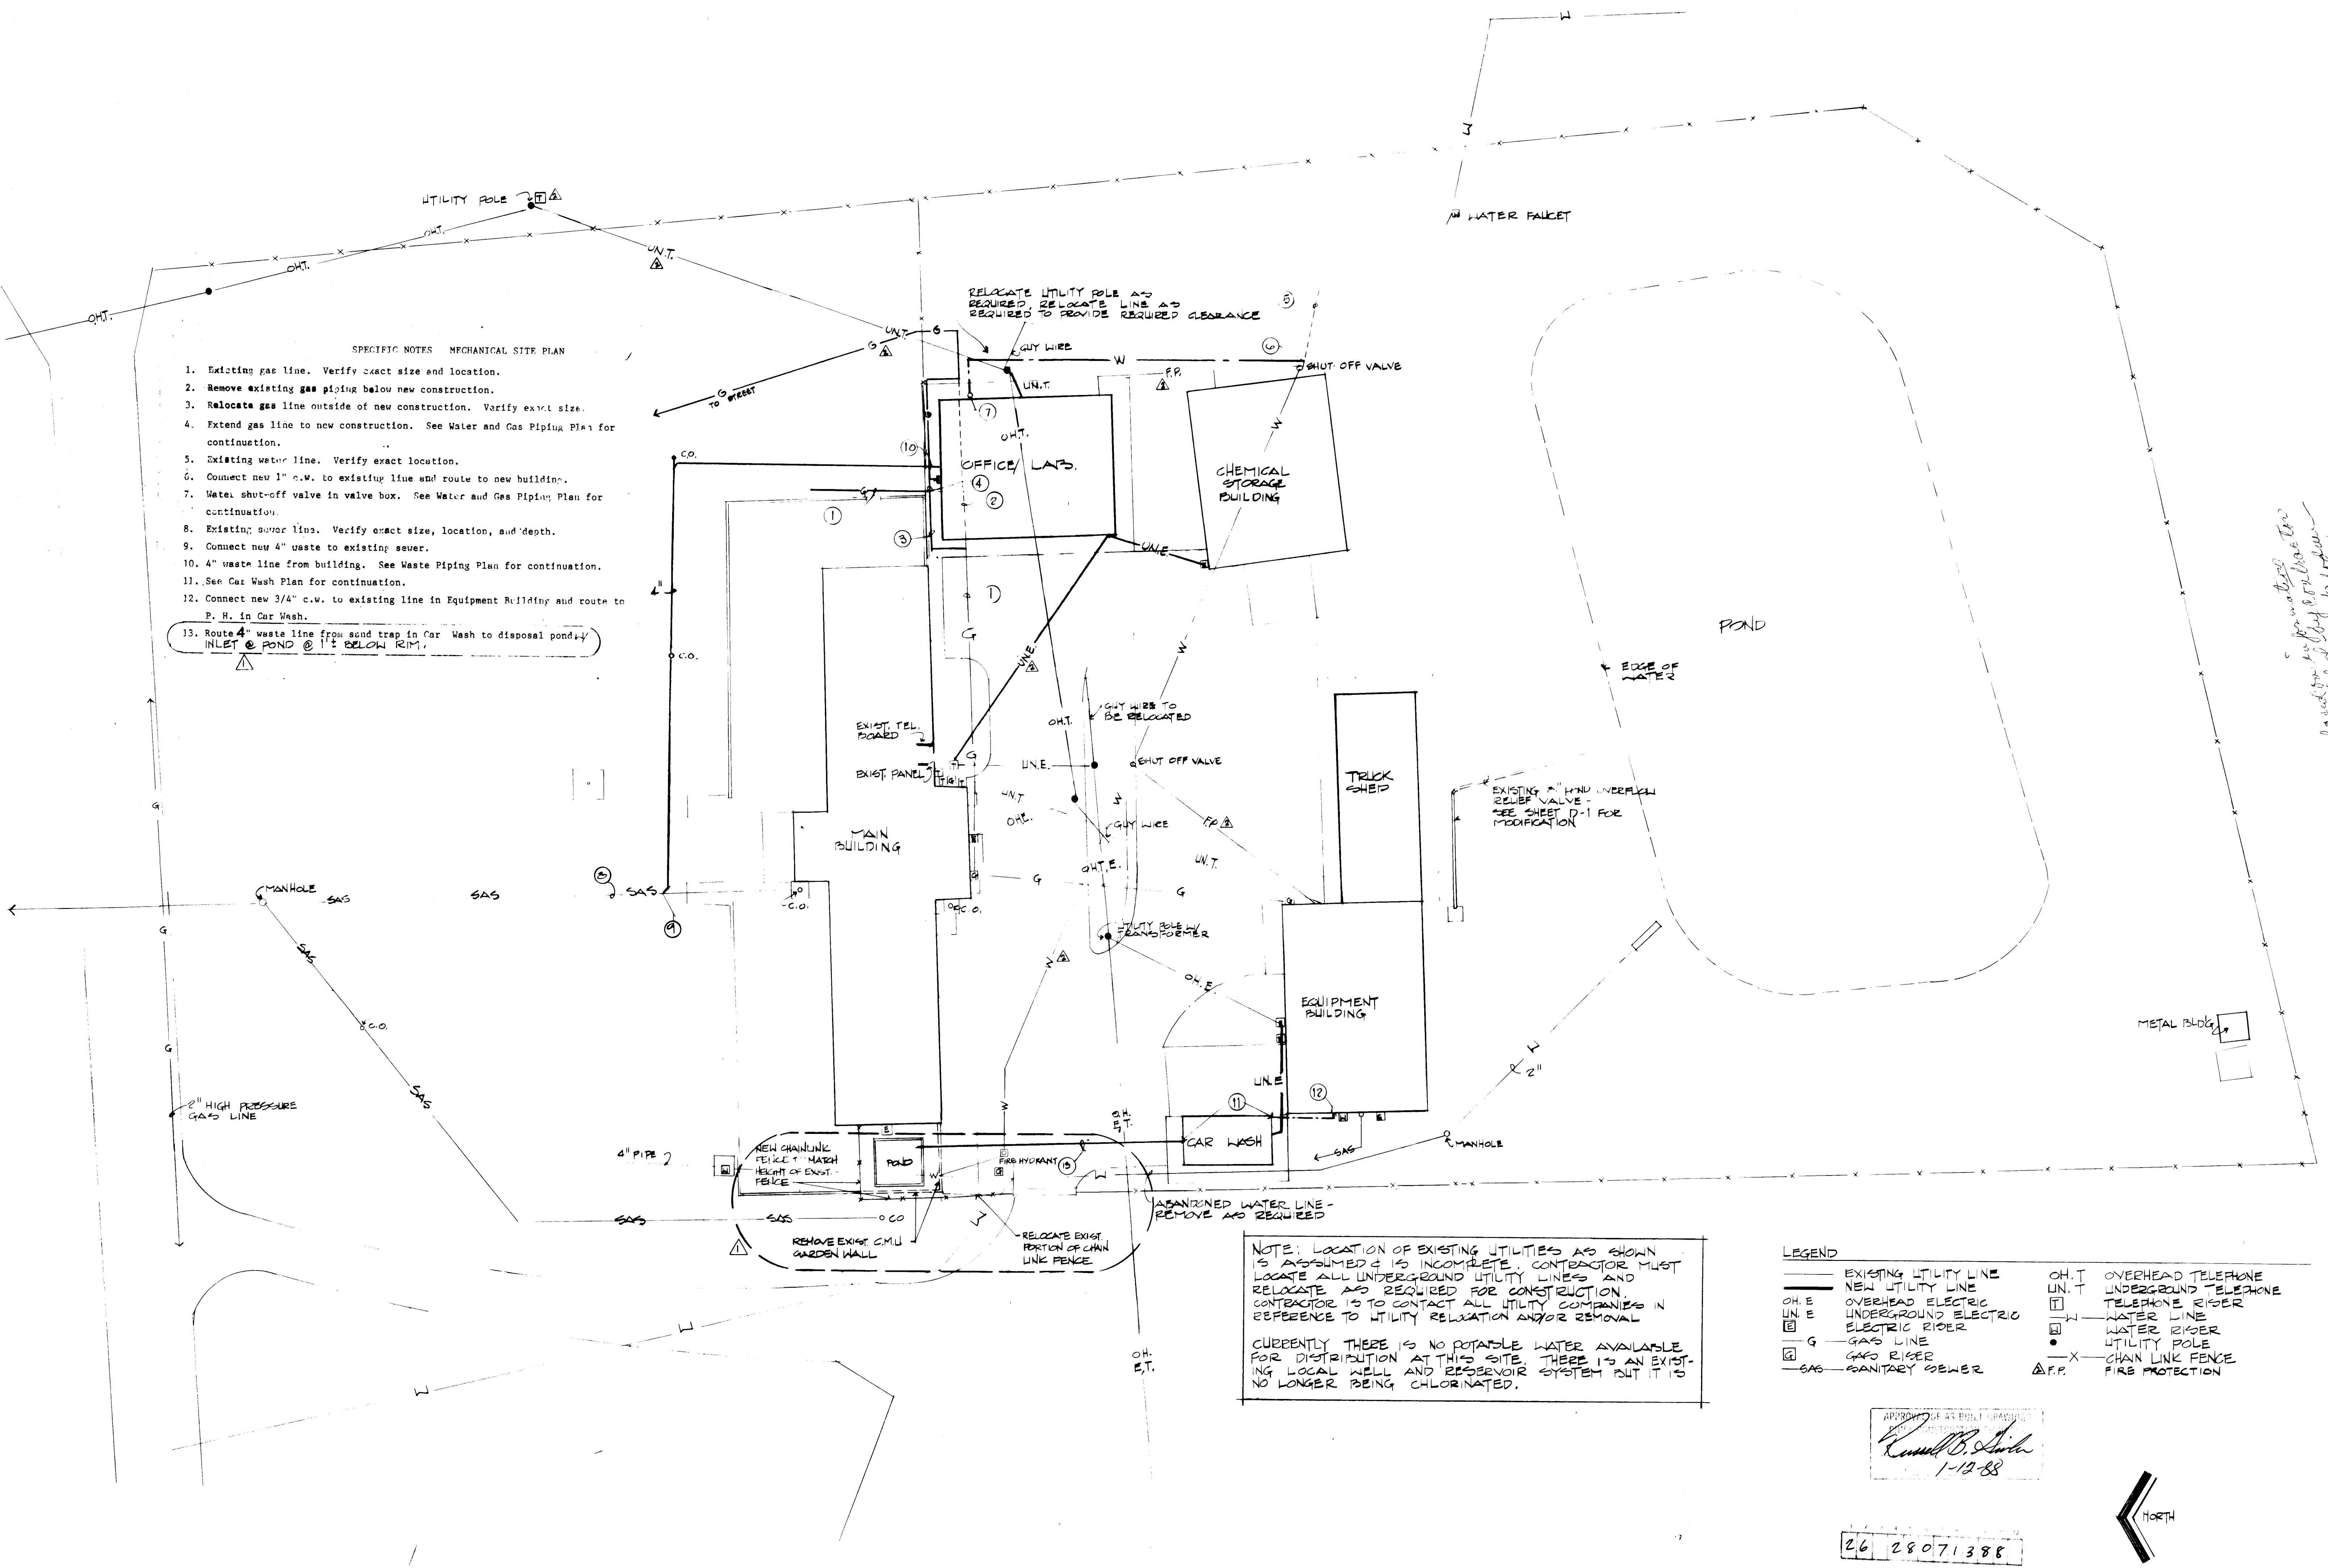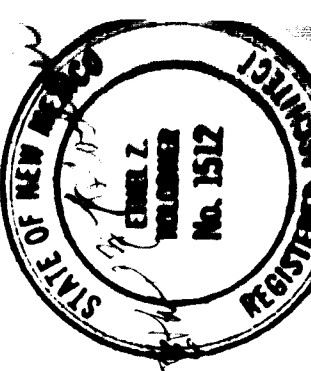

- SPECIFIC NOTES MECHANICAL SITE PLAN
1. Existing gas line. Verify exact size and location.
 2. Remove existing gas piping below new construction.
 3. Relocate gas line outside of new construction. Verify exact size.
 4. Extend gas line to new construction. See Water and Gas Piping Plan for continuation.
 5. Existing water line. Verify exact location.
 6. Connect new 1" c.w. to existing line and route to new building.
 7. Water shut-off valve in valve box. See Water and Gas Piping Plan for continuation.
 8. Existing sewer line. Verify exact size, location, and depth.
 9. Connect new 4" waste to existing sewer.
 10. 4" waste line from building. See Waste Piping Plan for continuation.
 11. See Car Wash Plan for continuation.
 12. Connect new 3/4" c.w. to existing line in Equipment Building and route to P. H. in Car Wash.
 13. Route 4" waste line from sand trap in Car Wash to disposal pond. INLET @ POND @ 1' BELOW RIM.

NOTE: LOCATION OF EXISTING UTILITIES AS SHOWN IS ASSUMED & IS INCOMPLETE. CONTRACTOR MUST LOCATE ALL UNDERGROUND UTILITY LINES AND RELOCATE AS REQUIRED FOR CONSTRUCTION. CONTRACTOR IS TO CONTACT ALL UTILITY COMPANIES IN REFERENCE TO UTILITY RELAXATION AND/OR REMOVAL.

CURRENTLY THERE IS NO POTABLE WATER AVAILABLE FOR DISTRIBUTION AT THIS SITE. THERE IS AN EXISTING LOCAL WELL AND RESERVOIR SYSTEM BUT IT IS NO LONGER BEING CHLORINATED.

LEGEND

—	EXISTING UTILITY LINE	OH.T	OVERHEAD TELEPHONE
—	NEW UTILITY LINE	UN.T	UNDERGROUND TELEPHONE
OH.E	OVERHEAD ELECTRIC	TEL.R	TELEPHONE RISER
UN.E	UNDERGROUND ELECTRIC	W	WATER LINE
E	ELECTRIC RISER	WR	WATER RISER
G	GAS LINE	U	UTILITY POLE
GR	GAS RISER	X	CHAIN LINK FENCE
SAS	SANITARY SEWER	F.P.	FIRE PROTECTION

APPROVED AS BUILT DRAWING
Robert B. Smith
1-12-88

26 28071388

