


CONSTRUCTION PLANS
FOR
WATERLINE EXTENSION
INDIAN SCHOOL NE TO CUMBRES NE
FOR
SKYVIEW CENTER


INDEX OF DRAWINGS

1	COVER SHEET
2	PLAN & PROFILE
3	PLAN & PROFILE

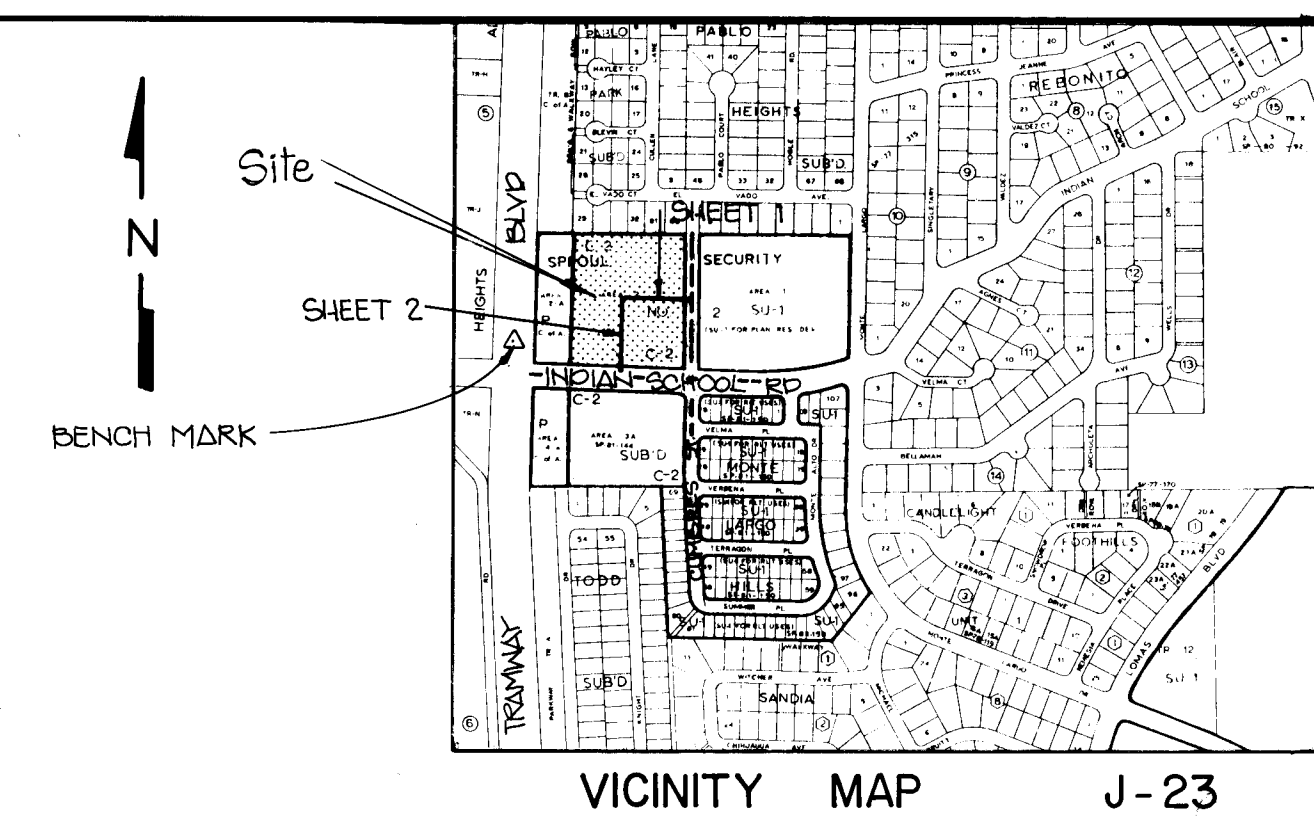

GENERAL NOTES:

1. All work detailed on these plans to be performed under contract shall, except as otherwise stated or provided for herein, be constructed in accordance with "City of Albuquerque Interim Standard Specifications for Public Works Construction, 1985."
2. Two (2) working days prior to any excavation, Contractor shall contact Line Locating Service at 765-1234, for location of existing lines.
3. The contractor shall prepare and submit a detailed traffic control plan, which is subject to the approval of the City Traffic Engineer, three (3) working days in advance of any required closures. See SECTION 19 of the General Conditions.
4. Stations shown are pipe centerline stations.
5. Prior to construction, the Contractor shall excavate and verify the horizontal and vertical locations of all obstructions. Should a conflict exist, the Contractor shall notify the engineer so that the conflict can be resolved with a minimum amount of delay. Facilities which are not specifically located with actual horizontal and vertical controls are located only approximately.
6. All utilities and utility service lines shall be installed prior to paving.
7. A disposal site for all excess earth material and for removal items shall be obtained by the Contractor. The site shall be in compliance with applicable environmental regulations and approved by the City Engineering Department. All costs incurred in obtaining a disposal site and haul thereto shall be considered incidental to construction and no direct payment will be made therefor.
8. It will be the responsibility of the Contractor to support all gas main and service lines where they are within the area of excavation.
9. Where a water line passes beneath or less than 18 in. above an existing sewer line, the sewer line shall be encased in concrete 6 in. thick as per the standard drawings, for at least 10 ft. on each side of the water line, or the sewer line shall be D.I. or C.I. pipe with pressure-type joints for at least 10 ft. on each side of the water line. This shall also apply where parallel water line is less than 10 ft. horizontally and less than 2 ft. above the sewer line.
10. All sewerlines in this project shall be constructed of DIP, ACP or PVC and installed in accordance with the specifications and standard drawings unless otherwise noted.
11. All waterlines in this project shall be constructed of DIP, ACP or PVC and installed in accordance with the specifications and standard drawings unless otherwise noted.
12. The contractor shall coordinate connection to existing water system in accordance with the specifications. (See SECTION 18 of the General Conditions.)
13. The Contractor shall repair and restore private or public property which is damaged during construction. (See SECTION 6 and SECTION 18 of the General Conditions.)
14. Dimensions shown are to the face of curb unless otherwise noted.

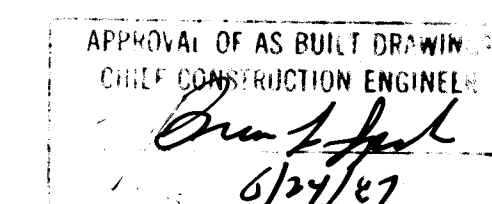


26 28760187

REV	SHEETS	CITY ENGINEER	DATE	USER	DEPT.	DATE	USER	DEPT.	DATE
△	2	J. L. Smith	11/3/86	J. L. Smith	UDD	11/9/86			
APPROVAL OF REVISIONS									



APPROVED FOR CONSTRUCTION	
DRAWING NO. 2876	
SHEET 1 OF 3	

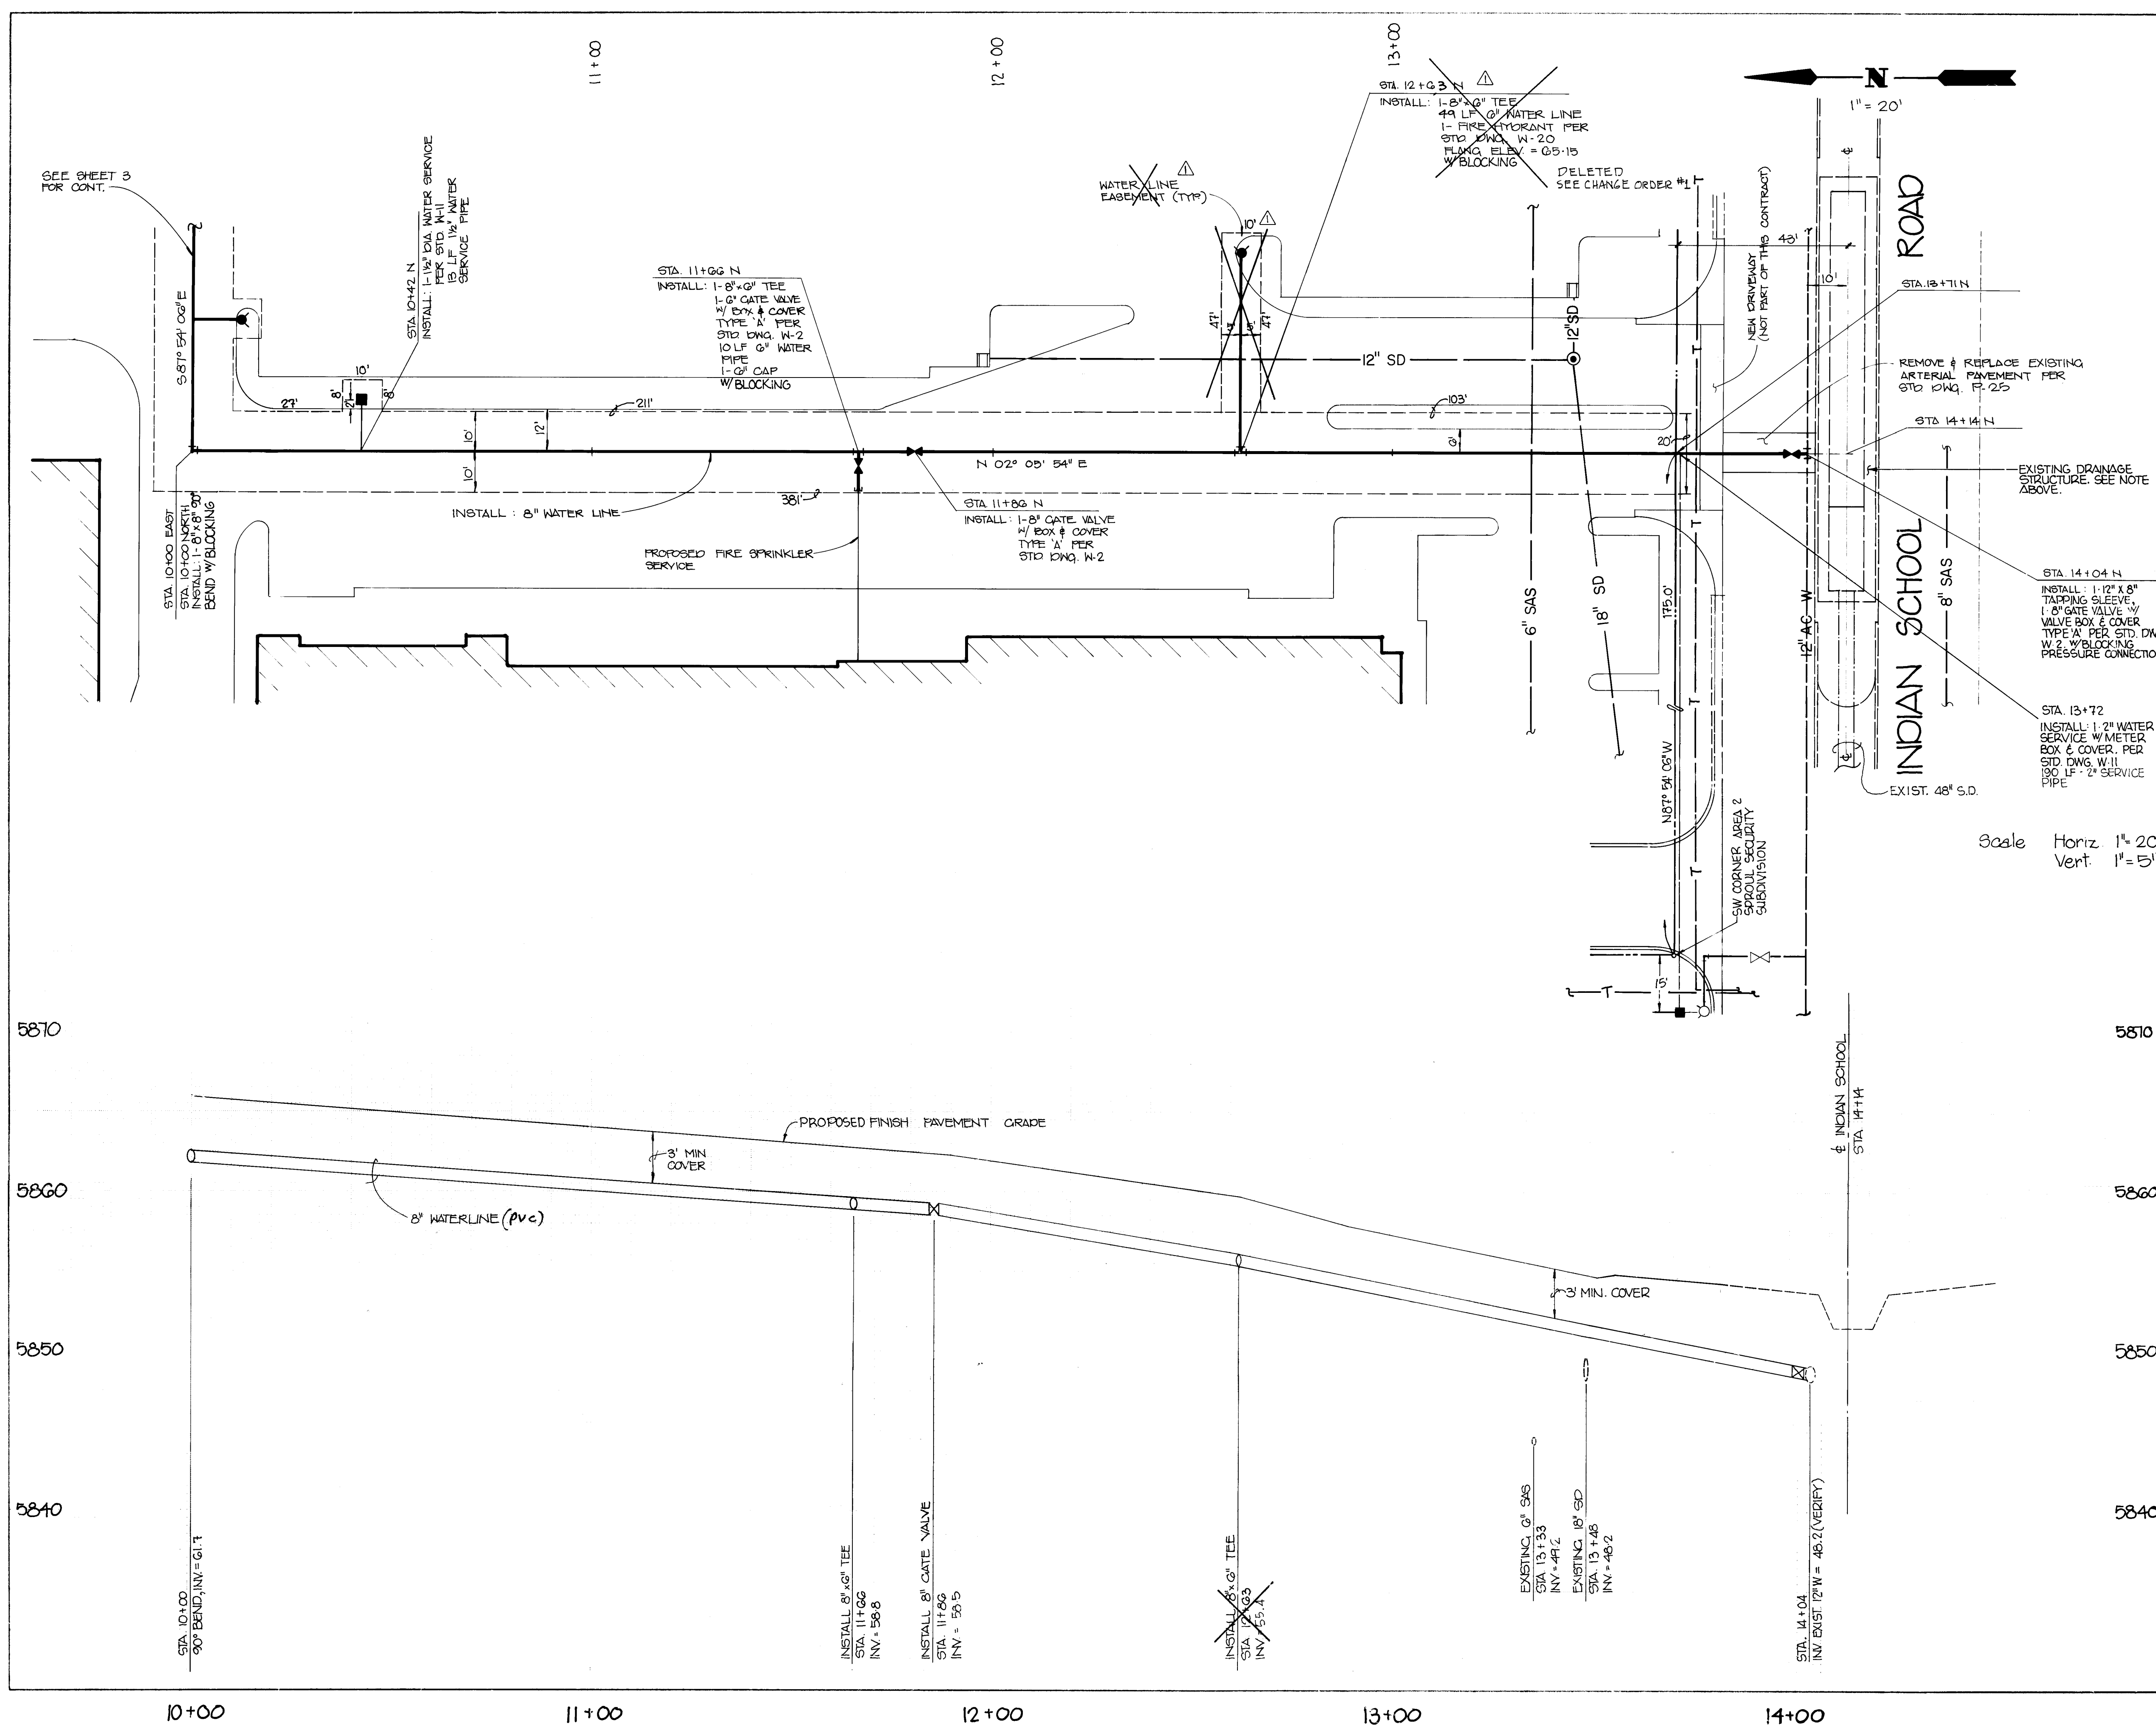

NOTE: BASIS OF BEARING IS PLAT OF AREA 2 SPROUL-SECURITY SUBDIVISION NO.2 BOOK C-8, FOLIO 117.

CONTRACTOR SHALL PROTECT EXISTING DRAINAGE STRUCTURE OR REMOVE AND REPLACE THAT PORTION WHICH IS DAMAGED OR COORDINATE WATERLINE INSTALLATION WITH TURNBAY CONSTRUCTION PER CITY PROJECT NO.

CONTRACTOR SHALL COORDINATE FIRE HYDRANT & METER BOXES WITH SITE PLAN.

TELEPHONE LOCATIONS ARE APPROXIMATE (VERIFY LOCATION)

Scale Horiz 1"=20'
Vert 1"=5'

AS BUILT INFORMATION		BENCH MARKS		SURVEY INFORMATION		ENGINEER'S SEAL	
CONTRACTOR	DATE	NO.	DATE	NO.	DATE	[Seal]	
Russ Pitney	6-11-87	ACB 1-123-A, 1982 - Standard ACB Brass					
INSPECTOR'S NAME	DATE	Tablet in Con. Mon. in 1" Dia. Mon. Box 182' North of Intersection of Tramway Blvd. and Indian School Road in Median.					
FILED NAME	DATE	Elevation = 5840.58					
VERIFICATION BY	DATE	Source: ACB Book, Page C-699 with Box No. 1					
CORRECTED BY	DATE						
MICRO-FILM INFORMATION							
RECORDED BY	DATE						
NO.							

REVISIONS			
NO.	DATE	REMARKS	BY
1	10-20-86	Delete Fire Hydrant @ Sta. 12+63 N	DMJM

DESIGNED BY	CHECKED BY	DATE	DATE	DATE
OPD	JJB			
MAT				



26 28760287

CITY OF ALBUQUERQUE
MUNICIPAL DEVELOPMENT DEPARTMENT
ENGINEERING DIVISION

TITLE: SKYVIEW CENTER WATERLINE

APPROVALS	ENGINEER	DATE	APPROVALS	ENGINEER	DATE
CITY Engineer	[Signature]	7/14/86	Liquid Waste	[Signature]	7/14/86
AEE Design	[Signature]	7/14/86	Traffic	NADWH	7/14/86
ACE Hydrology	[Signature]	7/14/86	Water	[Signature]	7/14/86

DRAWING NO. 2876 MAP NO. J-23 SHEET 2 OF 3

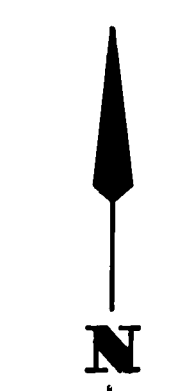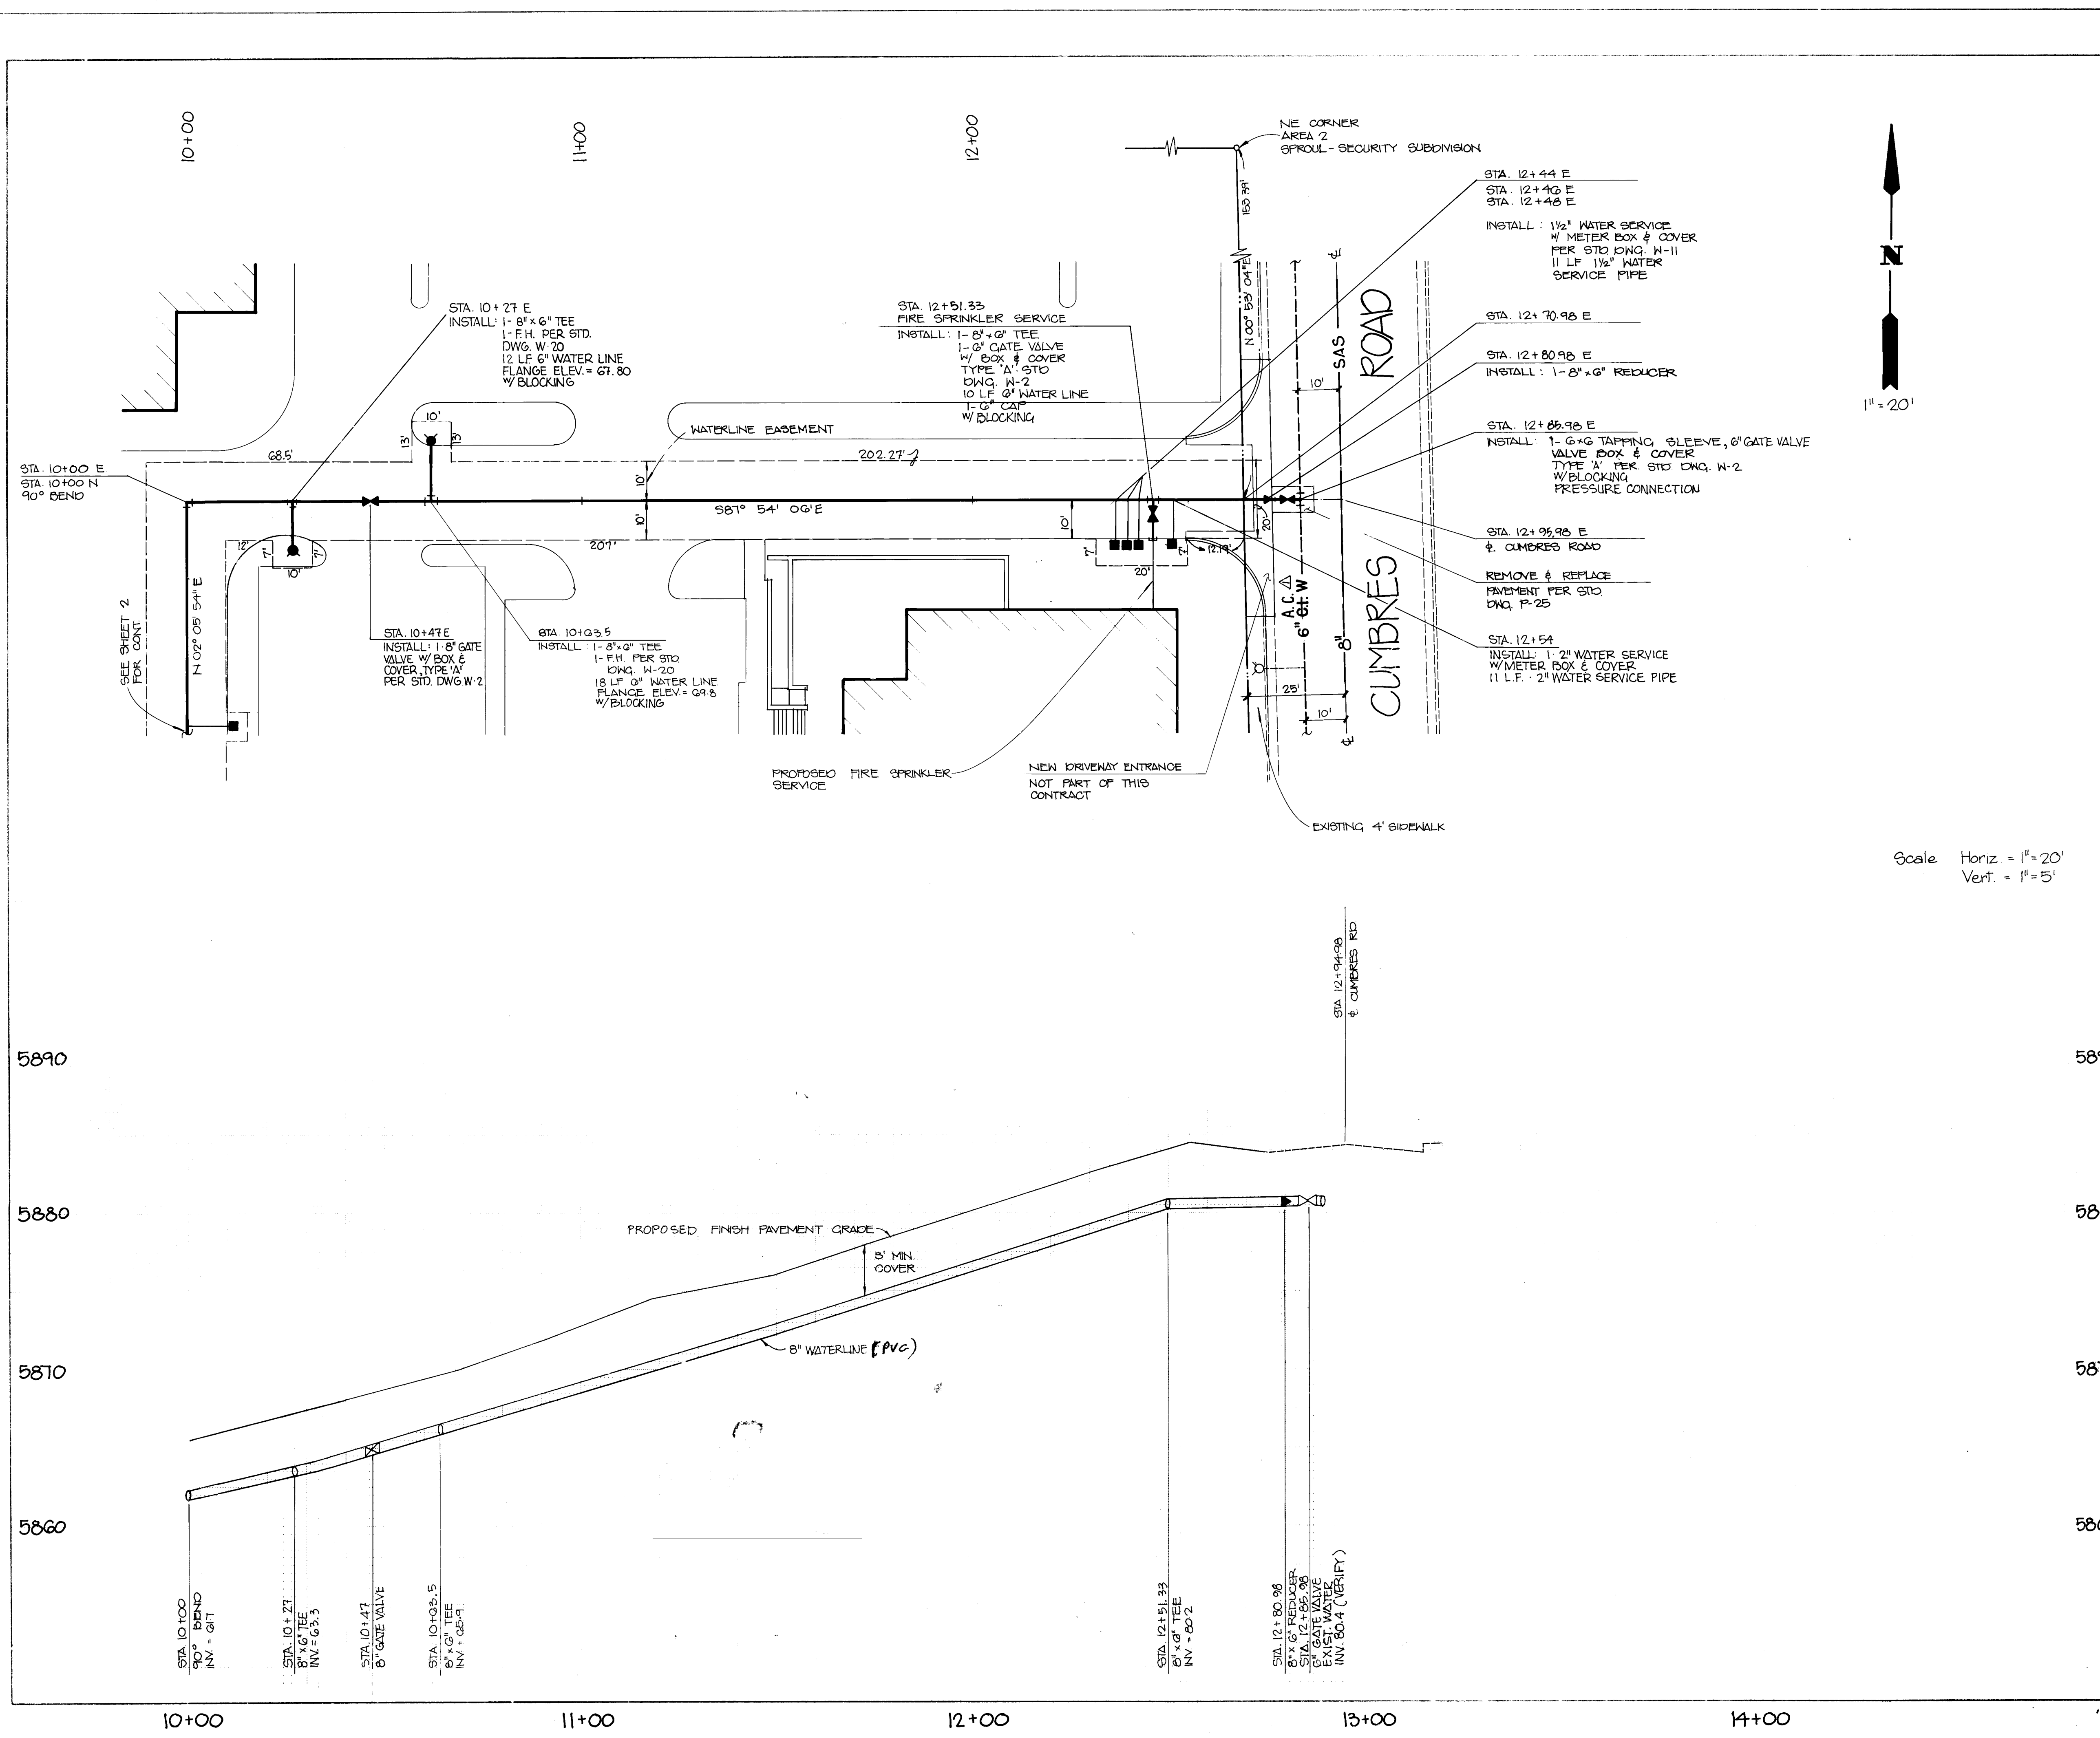

Scale Horiz = 1"=20'
Vert. = 1"=5'

NOTE: BASIS OF BEARING IS PLAT OF AREA 2 SPROUL - SECURITY SUBDIVISION NO. 2 BOOK O-8 FOLIO 117

CONTRACTOR SHALL COORDINATE FIRE HYDRANT & METER BOXES WITH SITE PLAN.

AS BUILT INFORMATION		BENCH MARKS		SURVEY INFORMATION		ENGINEER'S SEAL		REVISIONS		DESIGN		APPROVALS		ENGINEER		DATE	
CONTRACT NO.	1-1023-A, 1982	Standard ACS Pipes	Tablet in Con. Mon. in 11" Dia. Man Box, 182'	DATE	NO	BY	NO	DATE	NO	DATE	NO	DATE	NO	DATE	NO	DATE	NO
INSPECTOR	City of Albuquerque	North of Intersection of Tramway Blvd. and Indian School Road in Median	Elevation = 5840.55	DATE	NO	BY	NO	DATE	NO	DATE	NO	DATE	NO	DATE	NO	DATE	NO
FILE NO.	1-1023-A, 1982	Source: ACS Book, Page C-609 with Rev. No. 7		DATE	NO	BY	NO	DATE	NO	DATE	NO	DATE	NO	DATE	NO	DATE	NO
RECORDED BY	NO			DATE	NO	BY	NO	DATE	NO	DATE	NO	DATE	NO	DATE	NO	DATE	NO

26 2876 0387

CITY OF ALBUQUERQUE
MUNICIPAL DEVELOPMENT DEPARTMENT
ENGINEERING DIVISION

TITLE:
SKYVIEW CENTER
WATERLINE

APPROVALS	ENGINEER	DATE	APPROVALS	ENGINEER	DATE
City Engineer	<i>[Signature]</i>	7/11/86	Liquid Waste	<i>[Signature]</i>	7/11/86
A.C.E. Design	<i>[Signature]</i>	7/14/86	Traffic	NA DWH	1/11/86
A.C.E. Hydrology	<i>[Signature]</i>	7/14/86	Water	<i>[Signature]</i>	7/11/86

DRAWING NO. 2876 MAP NO. J-23 SHEET 3 OF 3