




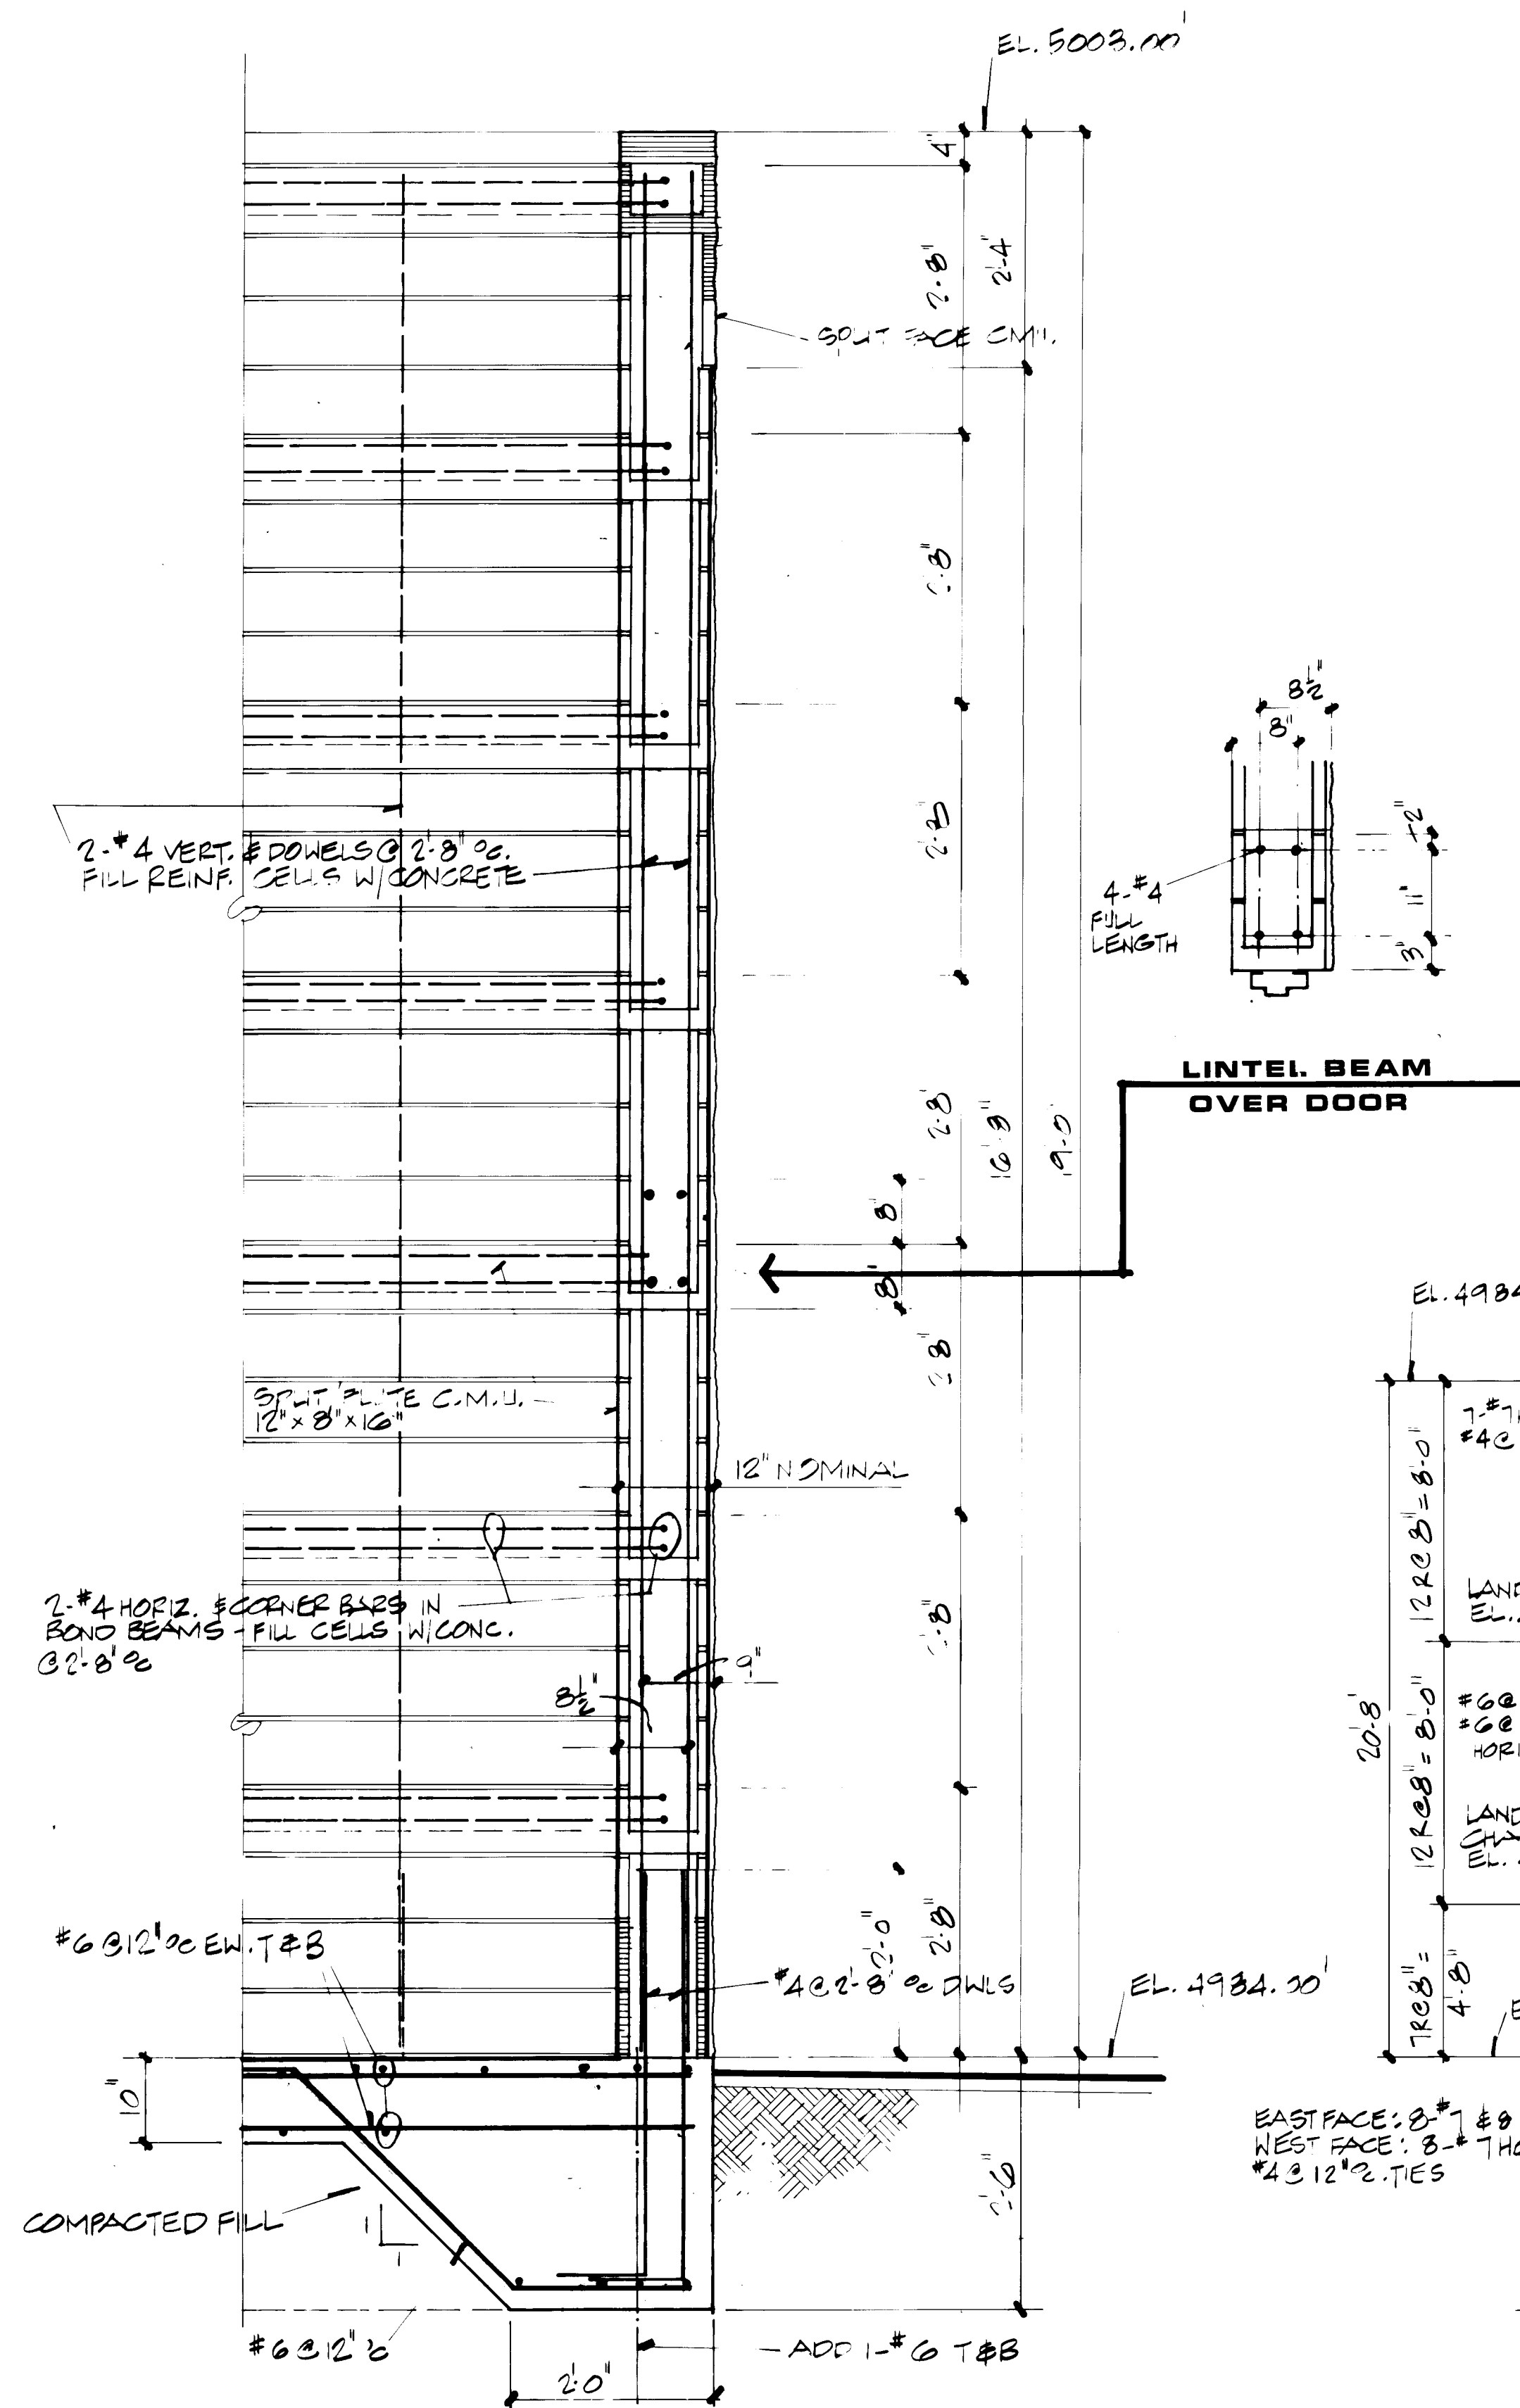

1 SECTION THRU WALL AT OXYGEN TANK
A10 $\frac{3}{8}'' = 1$

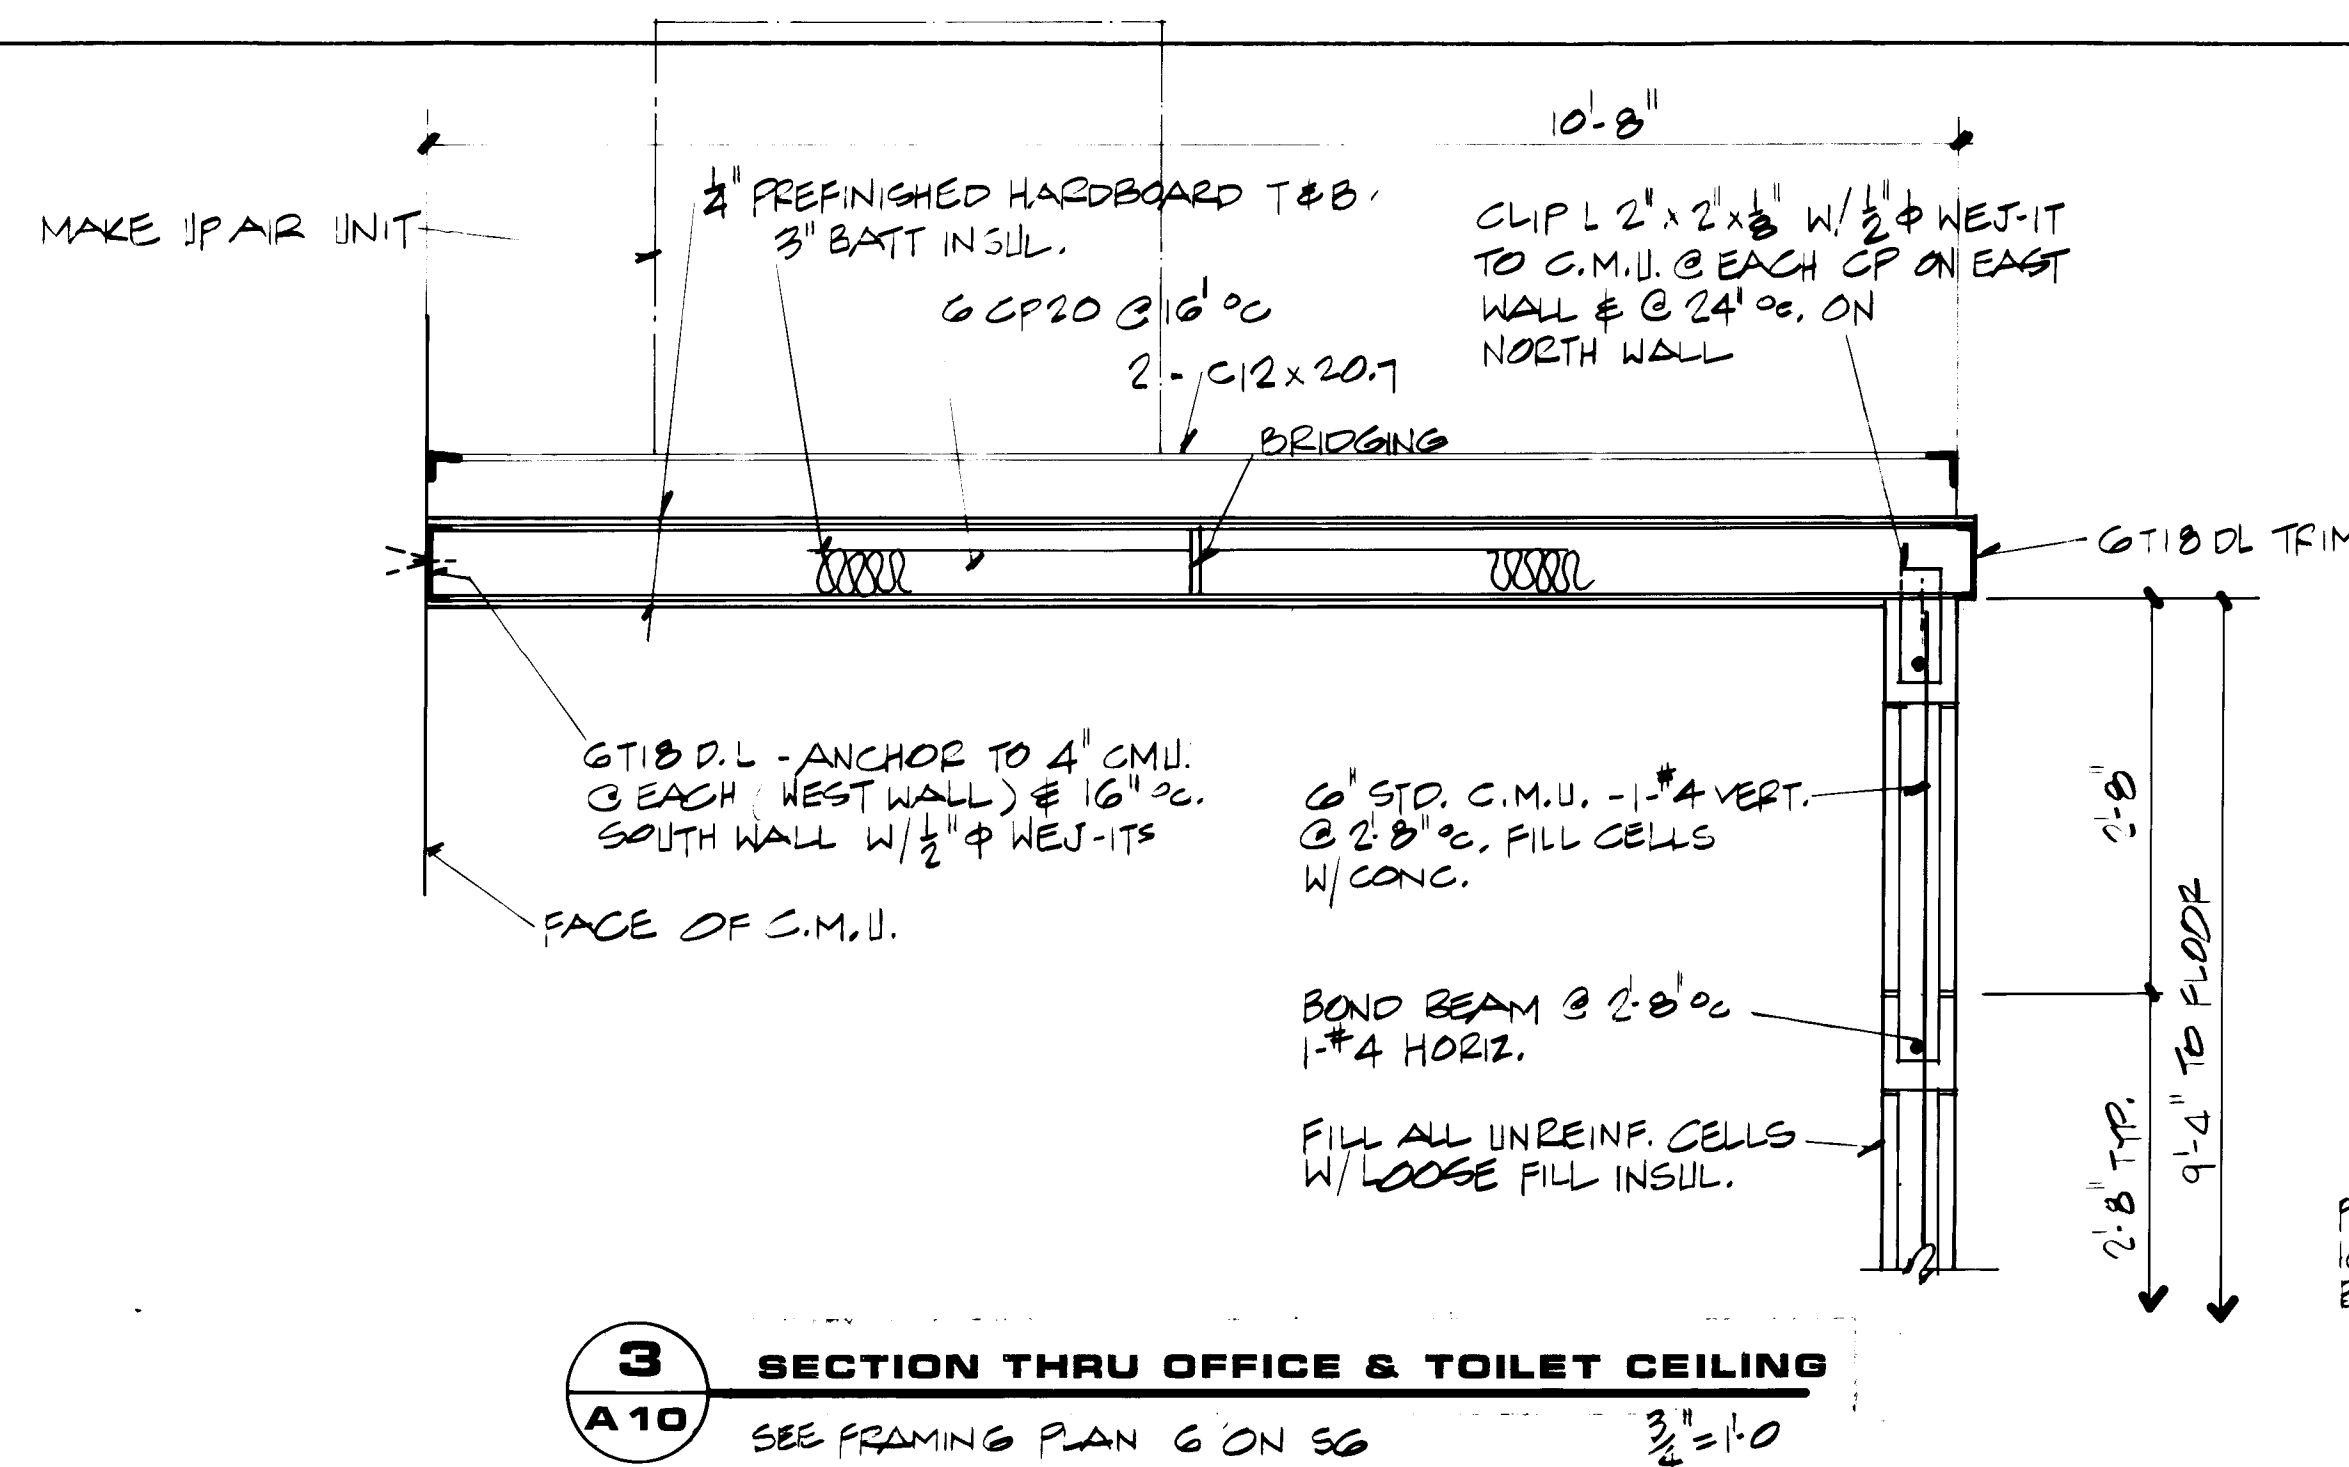

3 SECTION THRU OFFICE & TOILET CEILING
A10 SEE FRAMING PLAN G'ON 56 $3\frac{3}{4}'' = 1'-0$

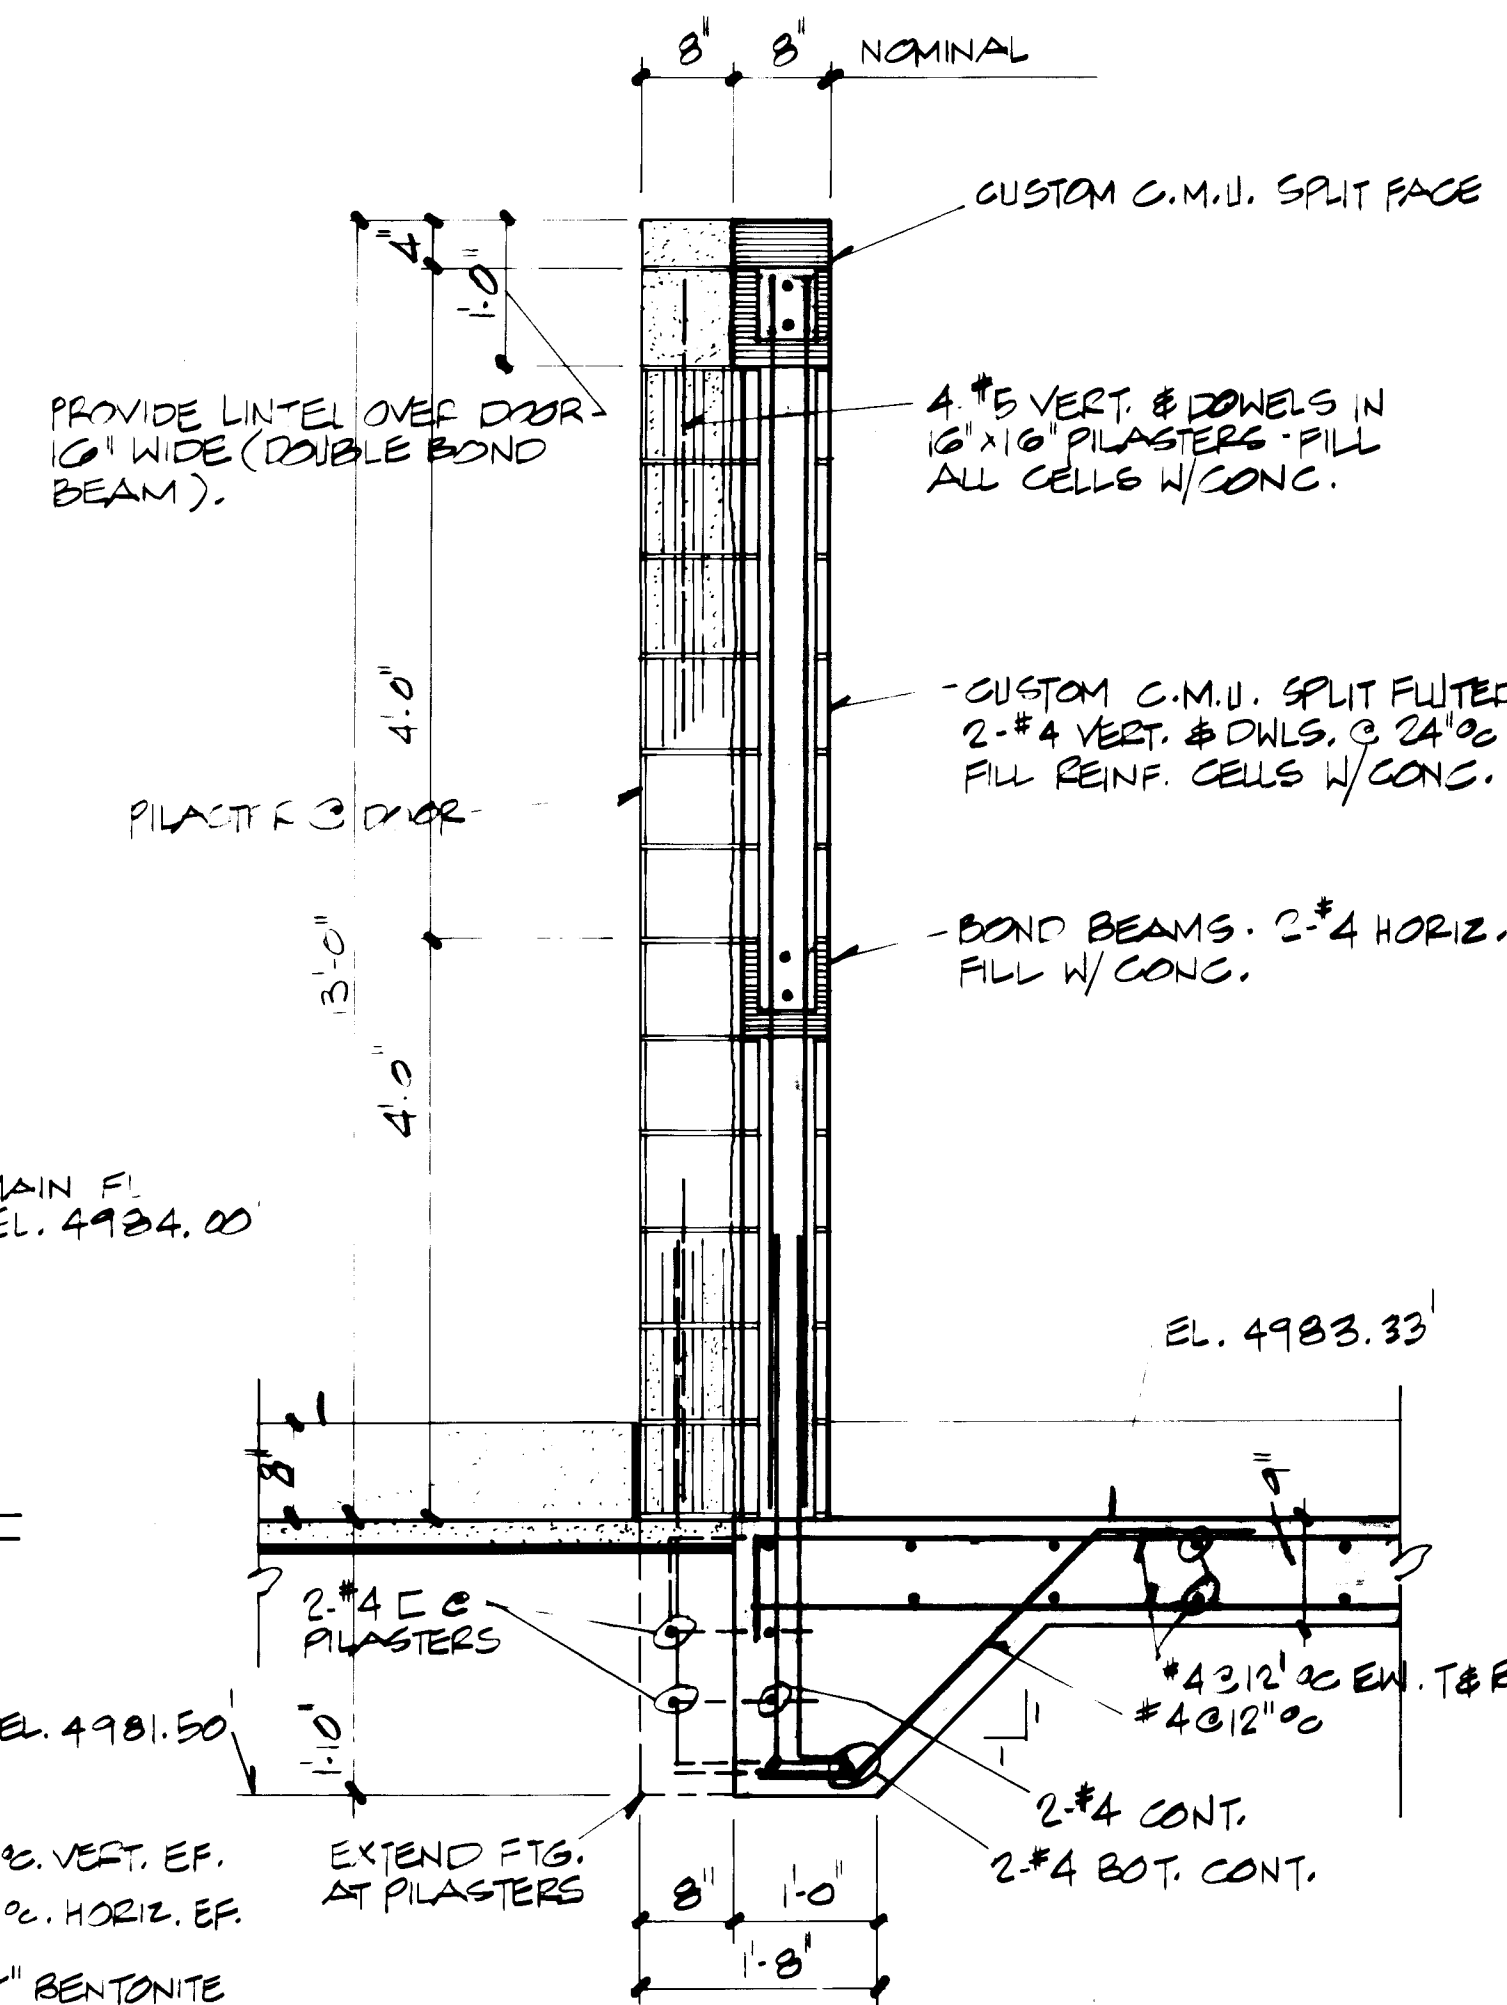

4 SECTION OF SCREEN WALL AROUND
A 10 TRANSFORMER AREA $3\frac{3}{4}" = 1'-0"$

RECORD DRAWING
DATE MAR 19 1986
BY J. W. Gwy, P.E.

BOVAY ENGINEERS, INC.
ALBUQUERQUE
 HOUSTON • SPOKANE • AUSTIN • BATON ROUGE

CITY OF ALBUQUERQUE
WATER RESOURCES DEPARTMENT
NEW LIFT STATION NO. 24

TITLE:					
SECTIONS AND DETAILS					
APPROVALS	ENGINEER	DATE	APPROVALS	ENGINEER	DATE
City Engineer			Liquid Waste		
A.C.E. - Design			Traffic		
A.C.E. - Hydrology			Water		
DRAWING NO. 2878		MAP NO.		SHEET OF	
				A10 45	

⚠ SHEAR KEY MAY BE PLACED IN EITHER DIRECTION AS LONG AS THE WATER STOP DOES NOT INTERFERE WITH THE REINFORCING STEEL