

CITY OF ALBUQUERQUE

MORROW & COMPANY
LANDSCAPE ARCHITECTS
210 La Veta Drive NE
Albuquerque, New Mexico 87108
505-268-2266

CONSULTANTS:
LEEDSHILL HERKENHOFF
CONSULTING ENGINEERS
GORDON J. DOUGLAS & ASSOC.
SURVEYOR
MOORE SURVEYING
SURVEYOR

PUBLIC WORKS DEPARTMENT WATER SYSTEMS FACILITIES LANDSCAPE IMPROVEMENTS

PROJECT NO. 3097

NOVEMBER, 1986

ND II

AS BUILT INDEX OF DRAWINGS

SHEET TITLE	SHEET NUMBER	SHEET TITLE	SHEET NUMBER
COVER		MILES WELL #1, RESERVOIR, AND PUMP STATION	86
NOTES AND LEGENDS	1	Grading Plan	87
ATRISCO WELL #3	2	Construction Plan	88
Grading Plan	3	Irrigation Plan	89
Demolition and Construction Plan	4	Planting Plan	90 (N.I.C.)
Planting Plan	5	PONDEROSA WELL #1, RESERVOIR, AND	91 (N.I.C.)
ATRISCO WELL #4	6	PUMP STATION	92 (N.I.C.)
Grading Plan	7	Grading Plan	93 (N.I.C.)
Construction Plan	8	Construction Plan	94 (N.I.C.)
Irrigation Plan	9	Irrigation Plan	95
Planting Plan	10	PONDEROSA WELL #2	96
BURTON WELL #1, RESERVOIR #1 AND #2, AND		Grading and Construction Plan	97
PUMP STATION		Irrigation Plan	98
Demolition Plan	11	Planting Plan	99
Irrigation Plan	12	PONDEROSA WELL #3	100
Planting Plan	13	Grading Plan	101
Planting Plan	14	Construction Plan	102
DON PUMP STATION		Irrigation Plan	103
Demolition Plan	15	Construction Plan	104
Grading Plan	16	Planting Plan	105
Construction Plan	17	PONDEROSA WELL #6	
Irrigation Plan	18	Grading Plan	106
Planting Plan	19	Construction Plan	107
DURNES RESERVOIR AND PUMP STATION		Irrigation Plan	108
Demolition Plan	20	Planting Plan	109
Construction Plan	21	RIDGECREST WELL #2	
Irrigation Plan	22	Grading Plan	110
Planting Plan	23	Construction Plan	111
EUBANK PUMP STATION (Add. Att. #1)		Irrigation Plan	112
Grading and Construction Plan	24 (N.I.C.)	Planting Plan	113
Irrigation Plan	25 (N.I.C.)	RIDGECREST WELL #4	
Planting Plan	26 (N.I.C.)	Grading Plan	114
GRIFGOS WELL #2		Construction Plan	115
Grading Plan	27	Irrigation Plan	116
Construction Plan	28	Planting Plan	117
Irrigation Plan	29	SANTA MANOR RESERVOIR AND PUMP STATION	
Planting Plan	30	Grading Plan	118
GRIFGOS WELL #3		Construction Plan	119
Grading Plan	31	Irrigation Plan	120 (N.I.C.)
Construction Plan	32	Planting Plan	121 (N.I.C.)
Irrigation Plan	33	Grading Plan	122 (N.I.C.)
Planting Plan	34	Construction Plan	123 (N.I.C.)
GRIFGOS WELL #4		Irrigation Plan	
Grading Plan	35	SANTA BARBARA WELL #1 AND RESERVOIR	
Construction Plan	36	Grading Plan	124
Irrigation Plan	37	Construction Plan	125
Planting Plan	38	Irrigation Plan	126
GUTIERREZ RESERVOIR AND PUMP STATION		Planting Plan	127
Grading Plan	39	SUPPER ROCK RESERVOIR AND PUMP STATION	
Construction Plan	40	Irrigation Plan	128
Irrigation Plan	41	Planting Plan	129
Planting Plan	42	THOMAS WELL #2	
KIVA RESERVOIR AND PUMP STATION (Add. Att. #2)		Grading Plan	130
Demolition Plan	43 (N.I.C.)	Construction Plan	131
Grading Plan	44 (N.I.C.)	Irrigation Plan	132
Construction Plan	45 (N.I.C.)	Planting Plan	133
Irrigation Plan	46 (N.I.C.)	THOMAS WELL #3	
Planting Plan	47 (N.I.C.)	Grading Plan	134
LEAVITT WELL #1 AND RESERVOIR		Construction Plan	135
Irrigation Plan	48	Irrigation Plan	136
Planting Plan	49	Planting Plan	137
LEAVITT WELL #2		THOMAS WELL #4	
Demolition Plan	50	Grading Plan	138
Grading Plan	51	Construction Plan	139
Construction Plan	52	Irrigation Plan	140
Irrigation Plan	53	Planting Plan	141
Planting Plan	54	VOL-ANDIA WELL #1, RESERVOIR, AND PUMP STATION	
LEYENDECKER WELL #1, RESERVOIR, AND		Grading Plan	142
PUMP STATION		Construction Plan	143
Demolition and Construction Plan	55	Irrigation Plan	144
Irrigation Plan	56	Planting Plan	145
Planting Plan	57	VOL-ANDIA WELL #2	
LEYENDECKER WELL #2		Grading Plan	146
Grading Plan	58	Construction Plan	147
Construction Plan	59	Irrigation Plan	148
Irrigation Plan	60	Planting Plan	149
Planting Plan	61	VOLCANO CLIFFS WELL #3	
LEYENDECKER #3 (Add. Att. #3)		Irrigation Plan	150
Grading Plan	62 (N.I.C.)	Planting Plan	151
Construction Plan	63 (N.I.C.)	W.A. WEBSTER WELL #1 AND RESERVOIR	
Irrigation Plan	64 (N.I.C.)	Grading and Construction Plan	152
Planting Plan	65 (N.I.C.)	Irrigation Plan	153
LINDA VISTA RESERVOIR AND PUMP STATION		Planting Plan	154
Grading Plan	66	Grading Plan	155 (N.I.C.)
Construction Plan	67	Construction Plan	156 (N.I.C.)
Irrigation Plan	68	Irrigation Plan	157 (N.I.C.)
Irrigation Plan	69	Planting Plan	158 (N.I.C.)
Planting Plan	70	WEST MESA WELL #4	
Planting Plan	71	Grading Plan	159
LOMAS RESERVOIR #1 AND #2, AND		Construction Plan	160
PUMP STATION		Irrigation Plan	161
Grading Plan	72	Planting Plan	162
Construction Plan	73	YALE RESERVOIR AND PUMP STATION (Add. Att. #6)	
Irrigation Plan	74	Demolition Plan	163 (N.I.C.)
Irrigation Plan	75	Irrigation Plan	164 (N.I.C.)
Planting Plan	76	Planting Plan	165 (N.I.C.)
Planting Plan	77	YALE WELL #3	
LOMAS WELL #1		Grading Plan	166
Grading Plan	78	Construction Plan	167
Construction Plan	79	Irrigation Plan	168
Irrigation Plan	80	Planting Plan	169
Planting Plan	81	YALE WELL #4	
LOVE WELL #7		Grading Plan	170
Grading Plan	82	Construction Plan	171
Construction Plan	83	Irrigation Plan	172
Irrigation Plan	84	Planting Plan	173
Planting Plan	85	DETAILS	174

261 3097 0186


GENERAL NOTES				
1.	All work detailed on these plans to be performed under contract shall, except as otherwise stated or provided for herein, be constructed in accordance with the City of Albuquerque Interim Standard Specifications for Public Works Construction, 1985.			
2.	The CONTRACTOR shall install construction locks on the gates of all sites as instructed by the Water Systems Division, Public Works Department to enable the CONTRACTOR to have ready access to the sites. Access to well houses for the installation of the irrigation controller shall be coordinated with the Water Systems Division, Public Works Department. The CONTRACTOR shall contact the Water Systems Division personnel at 823-4200 two full working days prior to proposed time shut off or to arrange for access to the well house or other building as needed.			
3.	The Contractor shall be responsible for protecting, supporting, and maintaining service of all existing utilities.			
4.	The Contractor shall be responsible for locating all underground utilities, including City water, sanitary sewer, and storm drain lines. Any damage to existing utilities shall be restored to previous condition by the Contractor at his expense.			
5.	Where plans call for installation of gravel or bark mulch, CONTRACTOR shall excavate as needed for top of gravel or bark to be flush with adjacent finish grade.			
6.	Weed trees less than 2" caliper that are not specifically called out on plans shall be removed and properly disposed of as part of the general clean-up of the site, at no additional cost to the OWNER.			
7.	The CONTRACTOR shall perform a general clean-up of all sites, removing and properly disposing of all surface trash and miscellaneous debris.			
8.	Expansion joints shall be installed where new concrete abuts existing concrete or other hard surfaces.			
9.	Proposed asphalt abutting existing buildings shall be installed up to the stem wall of the building.			
10.	Proposed asphalt shall slope a minimum of 1% away from building.			
11.	Curb and gutter reference to City Standard Detail P-8 shall be as per Standard Curb and Gutter.			
12.	Contractor shall adjust height of all structures located in areas to be paved or graded to be flush with finish grade.			
13.	Contractor shall be responsible for obtaining and installing any approved, clean fill that may be necessary to complete grading operations (typical all sites).			
14.	Contractor shall be responsible for disposing of cut from grading operations as directed by Landscape Architect (typical all sites).			

IRRIGATION NOTES				
1.	Metered service line for irrigation taps shall be as per Standard City Detail W-11 and W-10.			
2.	All taps shall be pressure connections.			
3.	The proposed controller location indicated on the plans is schematic. Actual location of the controller will be within 20 horizontal feet from the location shown. The Contractor shall locate controller as directed by the Public Works Department. Electrical source will be a maximum of 20 horizontal feet from the proposed controller location.			
4.	Where crossing existing hard construction is shown on plans, the contractor shall saw-cut existing asphalt and/or concrete prior to trenching, remove and properly dispose of debris, install sleeve piping, compact subgrade to 95%, and replace asphalt and/or concrete to match existing areas.			
5.	The Contractor shall adjust all valves, bubblers, and sprinklers for optimum coverage, and shall install odd arc or adjustable nozzles when instructed by the Landscape Architect.			
6.	All existing mainline locations are schematic. It shall be the Contractor's responsibility to pot hole and field check to determine actual locations as an incidental requisite to the construction contract.			
7.	Conduit for 110 volt wires and 24 volt wires (See detail F-166) shall be rigid steel conduit.			
8.	The service line between the pressure connection and water meter shall be plastic tubing as per City Std. Specification 702.3.3.			
9.	Contractor shall install manual drains on the lateral piping at the lowest point to insure complete drainage of the lateral. Quantity shall be as required and shall be located on the "As Built" drawings. (Location shall be determined by the Contractor at time of installation.) See (A) (Minimum one per zone.)			
10.	All proposed irrigation piping shall be marked using marker tape and shall be laid horizontally 4" above piping. Piping laid in common trenches shall have marker tape for each pipe. Tape shall be 2" wide and marked "buried water line", blue in color and metallic for future location. Product is available from pipeline Material Inc. Albuquerque, New Mexico (505) 821-2626 (or approved equal).			
11.	24V wire shall be run from the controller to the closest irrigation trench, minimizing the amount of trenching required for the installation of the wire. The Contractor shall review the proposed routing of the 24 volt wire with the Landscape Architect and have the route approved by the Landscape Architect prior to installation.			
12.	The Contractor shall wire 120 V AC to the closest 120 V general purpose branch circuit. The connection shall be made in a junction box. Associated breaker shall be labeled "Irrigation Control Panel". For bidding purposes, the Contractor shall utilize 25'-0" horizontal feet of 1/2" EMT with 2 #12's with one #12 ground. Actual location for connection shall be determined by the inspector in the field.			
13.	All 24 volt wire shall be marked with a 6" wide yellow marker tape and marked "Warning-Electrical". Lay marker tape horizontally 4" above wire.			
14.	In addition to other specified tests and inspections, the irrigation systems shall be performance tested and witnessed by the Compliance Officer from the City of Albuquerque Health and Environment Department for conformance with the provisions of the Waste Water Ordinance.			

PLANT LIST				
SYMBOL	BOTANICAL NAME	COMMON NAME	SIZE	QTY.
TREES				
ACE SAC	Acer saccharinum	Silver Maple	15 gallon	1
CAR LIL	Carya illinoensis	Pecan	15 gallon	3
CAR LIL	Carya illinoensis	Pecan	24" box	4
CHI LIN	Chilopsis linearis	Desert Willow	5 gallon	51
CHI LIN	Chilopsis linearis	Desert Willow	15 gallon	3
CUP LEY	Cupressocyparis leylandii	Leyland False Cypress	15 gallon	49
CUP ARI	Cupressus arizonica	Arizona Cypress	15 gallon	151
ELA ANG	Elaeagnus angustifolia	Russian Olive	15 gallon	5
FRA PEN	Fraxinus pennsylvanica	Green Ash	15 gallon	6
FRA VEL 'MOD'	Fraxinus velutina 'Modesto'	Modesto Ash	15 gallon	119
FRA VEL 'MOD'	Fraxinus velutina 'Modesto'	Modesto Ash	24" box	7
GLE TRI 'INE 'SHA'	Gleditsia triacanthos inermis 'Shadenaster'	Shadenaster Honey Locust	15 gallon	2
GLE TRI 'INE 'SUN'	Gleditsia triacanthos inermis 'Sunburst'	Sunburst Honey Locust	15 gallon	111
JUN SCO	Juniperus scopulorum	Rocky Mountain Juniper	15 gallon	8
JUN VIR	Juniperus virginiana 'Canadensis'	Canadensis Juniper	15 gallon	3
KOE PAN	Koeleruteria paniculata	Goldenrain Tree	15 gallon	63
KOE PAN	Koeleruteria paniculata	Goldenrain Tree	24" box	11
MAL SYL	Malus sylvestris	Apple Tree	15 gallon	43
MOR ALB	Morus alba	Fruitless Mulberry	15 gallon	13
PIN ELB	Pinus eldarica	Afghan Pine	15 gallon	182
PIN MIG	Pinus nigra	Austrian Pine	15 gallon	86
PIN PON	Pinus ponderosa	Ponderosa Pine	15 gallon	44
PIN SYL	Pinus sylvestris	Scotch Pine	15 gallon	17
PLA ACE	Platanus acerifolia	London Plane Tree	15 gallon	50
PLA MRE	Platanus wrightii	Arizona Sycamore	15 gallon	6
POP ACU	Populus aluminata	Lanceleaf Cottonwood	15 gallon	67
POP FRE	Populus fremontii	Fremont Cottonwood	15 gallon	43

SYMBOL	BOTANICAL NAME	COMMON NAME	SIZE	QTY.
TREES				
POP NIG 'ITA'	Populus nigra 'Italica'	Lombardy Poplar	15 gallon	118
PRU BLI	Prunus birelana	Birelana Plum	15 gallon	1
PRU PER	Prunus persica	Common Peach	15 gallon	14
ROB PSE	Robinia pseudoacacia	Black Locust	15 gallon	52
ROB PSE	Robinia pseudoacacia	Black Locust	24" box	3
SAP DRU	Sapindus drummondii	Soap Tree	5 gallon	5
TRA FOR	Trachycarpus fortunei	Chinese Windmill Palm	24" box	12
TRA FOR	Trachycarpus fortunei	Chinese Windmill Palm	15 gallon	10
TRA FOR	Trachycarpus fortunei	Chinese Windmill Palm	7 gallon	2
SHRUBS				
ATR CAN	Atriplex canescens	Fourwing Saltbush	5 gallon	52
BAC PIL	Baccharis pilularis	Dwarf Coyote Bush	1 gallon	1021
BER TRI	Berberis triacanthophora	Three-spine Barberrry	5 gallon	12
CHR GRE	Chrysothamnus Greenei	Green Rabbitbrush	5 gallon	80
CHR NAU	Chrysothamnus nauseosus	Rubber Rabbitbrush	5 gallon	400
COT API	Cotoneaster apiculatus	Cranberry Cotoneaster	5 gallon	25
COT HOR	Cotoneaster horizontalis	Rock Cotoneaster	5 gallon	21
FAL PAR	Fallugia paradoxa	Apache Plume	5 gallon	86
FOR NEO	Forestiera neomexicana	New Mexico Olive	5 gallon	16
FOR GOL	Forsythia 'Linwood Gold'	Linwood Gold Forsythia	5 gallon	21
GUT SAR	Gutierrezia sarothrae	Snakeweed	1 gallon	78
JAS NUD	Jasminum nudiflorum	Flowering Jasmine	5 gallon	79
JUN CHI 'ARM'	Juniperus chinensis 'Armstrong'	Armstrong Juniper	5 gallon	58
JUN CHI PAR	Juniperus chinensis procumbens 'Nana'	Japanese Garden Juniper	5 gallon	101
JUN SAB 'BRO'	Juniperus sabina 'Broadmoor'	Broadmoor Juniper	5 gallon	102
JUN SAB 'TAM'	Juniperus sabina 'Tamariscifolia'	Tam Juniper	5 gallon	172
LAG IND	Lagerstroemia indica	Crape Myrtle	5 gallon	18

IRRIGATION LEGEND (cont.)				
2" BRASS AUTOMATIC VALVE ASSEMBLY, WEATHERMATIC 8024 BCR-20	SEE DETAIL	(C)	(17)	
1" AUTOMATIC VALVE AND ATMOSPHERIC VACUUM BREAKER ASSEMBLY, WEATHERMATIC 8024 BCR-10 WITH CHAMPION 262-JD	SEE DETAIL	(D)	(17)	
MANUAL DRAIN ASSEMBLY, SIZE 3/4"	SEE DETAIL	(A)	(17)	
SOLVENT WELD CAP (LINE SIZE)		(B)	(17)	
CONTROLLER, TORO 171-06-01 EIGHT STATION WALL MOUNT CONTROLLER	SEE DETAIL	(E)	(17)	
SLEEVE PIPING, CLASS 200 PVC (TWO SIZES LARGER THAN PIPE TO BE SLEEVED), (SLEEVE PIPE FOR 24 VOLT WIRE SHALL BE 1 1/4" CLASS 200 PVC)				
LATERAL PIPING, SCH. 40 PVC - 18" BURY (24" BURY FOR LATERALS FEEDING 12" POP-UP SPRINKLERS)				
MAINLINE PIPING, SCH. 80 PVC - 30" BURY				
TORO 570-HP, 12" POP-UP PRESSURE COMPENSATING SPRINKLER WITH INTERNAL CHECK VALVE	SEE DETAIL	(E)	(17)	
NOZZLE				
12-0-PC	12"	.7	25	
12-120-PC	12"	.8	25	
12-4-PC	12"	1.0	25	
12-240-PC	12"	1.2	25	
12-270-PC	12"	1.5	25	
12-4-PC	12"	2.0	25	
ADJ-PC	12"	.8	20	
4-EST-PC	4" X 30"	1.2	30	
4-EST-PC	4" X 15"	.6	30	
TORO 570-P, 3" POP-UP PRESSURE COMPENSATING SPRINKLER WITH INTERNAL CHECK VALVE	SEE DETAIL	(A)	(17)	
NOZZLE				
12-0-PC	12"	.7	25	
12-120-PC	12"	.8	25	
12-4-PC	12"	1.0	25	
12-240-PC	12"	1.2	25	
12-270-PC	12"	1.5	25	
12-4-PC	12"	2.0	25	
ADJ-PC	12"	.8	20	
4-EST-PC	4" X 30"	1.2	30	
4-EST-PC	4" X 15"	.6	30	
9-SST-PC	9" X 18"	1.2	30	
HUNTER I-20 GEAR DRIVE SPRINKLER	SEE DETAIL	(C)	(17)	
HUNTER I-20 GEAR DRIVE SPRINKLER	SEE DETAIL	(C)	(17)	
HUNTER I-20 GEAR DRIVE SPRINKLER	SEE DETAIL	(C)	(17)	
TORO 570-P, 3" POP-UP PRESSURE COMPENSATING POP-UP BUBBLER ASSEMBLY WITH INTERNAL CHECK VALVE AND F3-100-PC 1.0 GPM NOZZLE	SEE DETAIL	(E)	(17)	
LATERAL MANUAL DRAIN 1/2" LINE AUTOMATIC DRAIN				
24 VOLT WIRE ROUTE, 30" BURY				

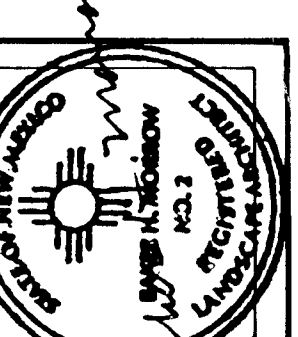

MORROW & COMPANY
LANDSCAPE ARCHITECTS
210 La Vista Drive NE
Albuquerque, New Mexico 87108
505-268-2266

NOVEMBER 1986

LANDSCAPING IMPROVEMENTS FOR
WATER SYSTEM FACILITY SITES
WATER SYSTEMS DIVISION
NEW MEXICO DEPARTMENT OF
ALBUQUERQUE, NEW MEXICO


NOTES AND LEGENDS

AS BUILT

SHEET
102
(of 110)


630970286

1 2 3 4 5 6 7 8 9 10 11 12

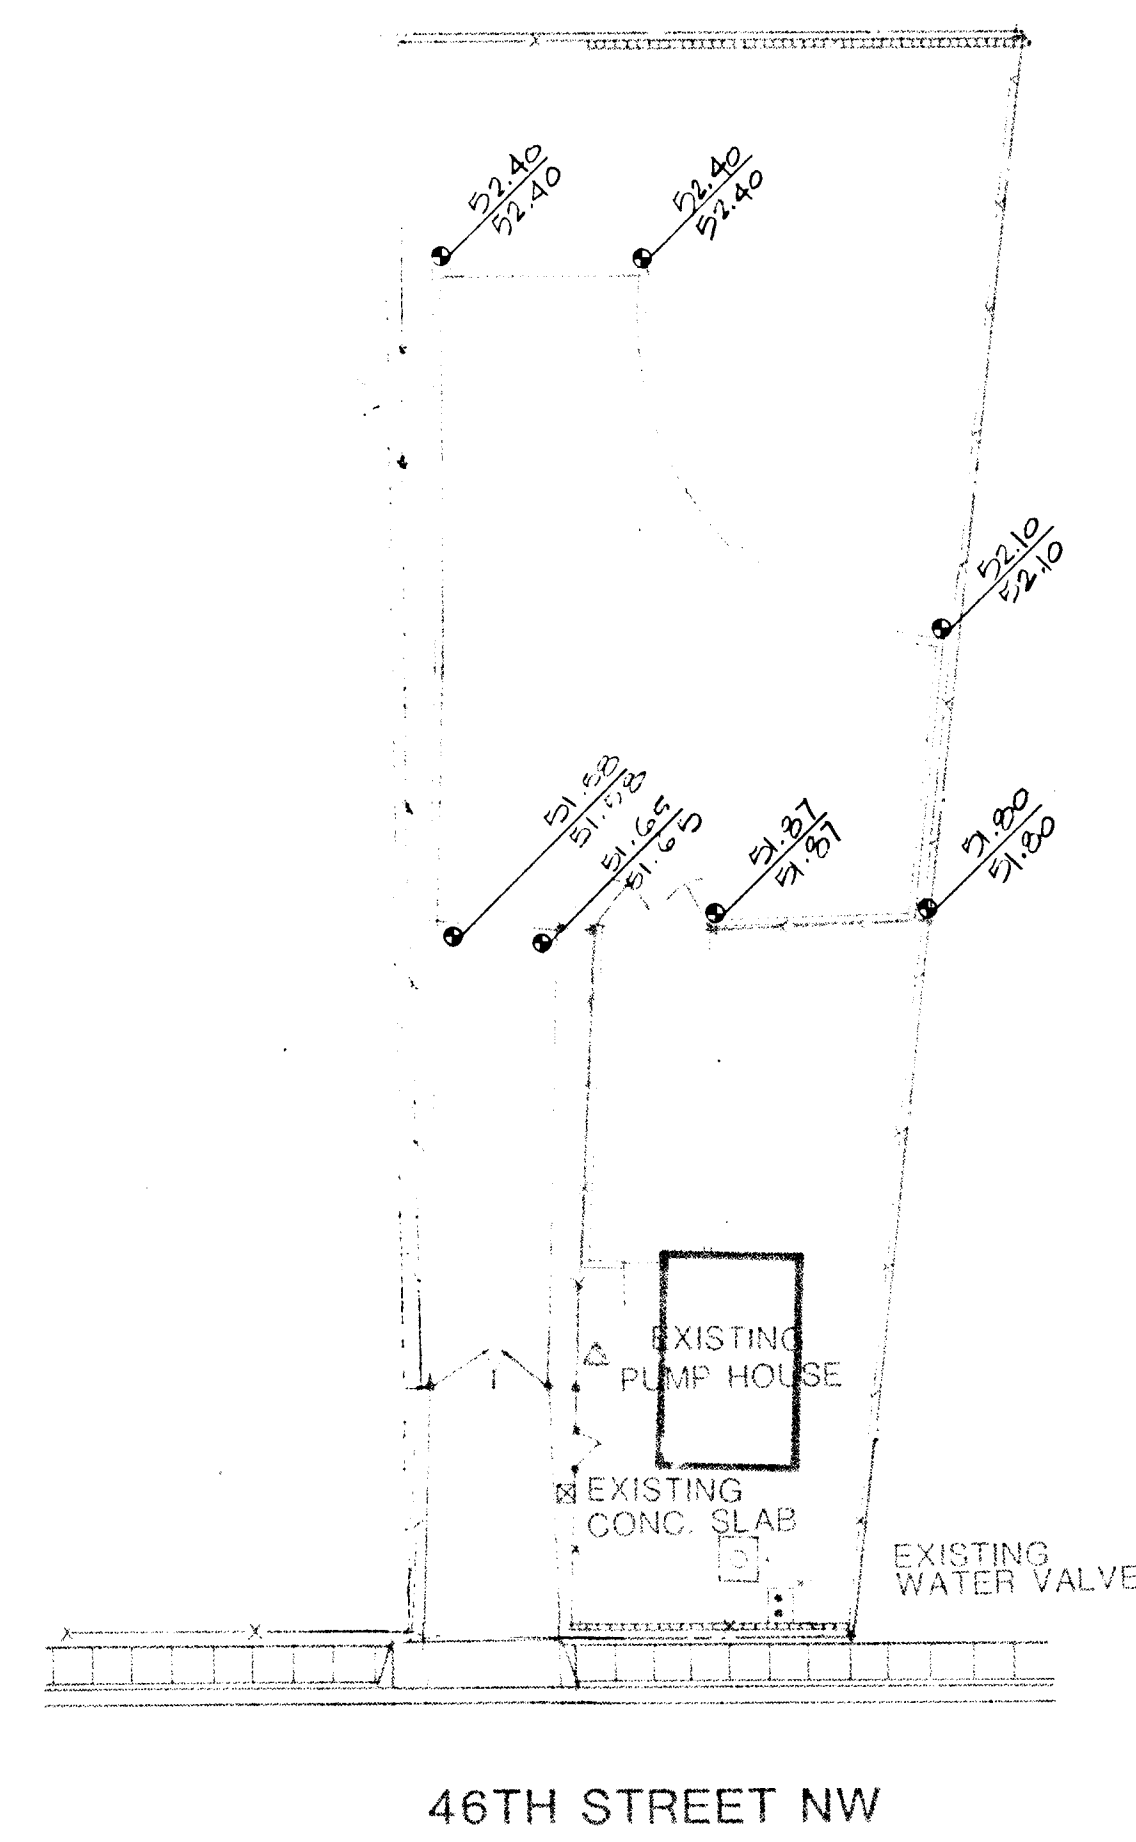

26 3097 0386

SCALE 1"=20'-0"

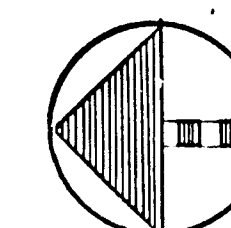


LANDSCAPING IMPROVEMENTS FOR
WATER SYSTEM FACILITY SITES
WATER SYSTEMS DIVISION
CITY OF ALBUQUERQUE
ALBUQUERQUE, NEW MEXICO


ATRISCO WELL #3
324 46TH ST. NE
GRADING PLAN

AS BUILT

NOVEMBER
1986

MORROW & COMPANY
LANDSCAPE ARCHITECTS
210 La Veta Drive NE
Albuquerque, New Mexico 87108
505-268-2266

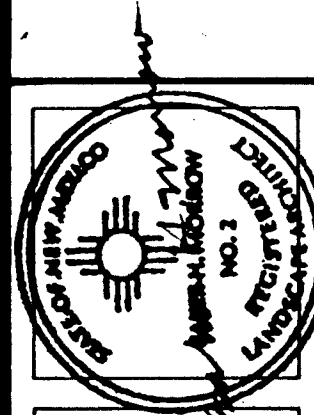


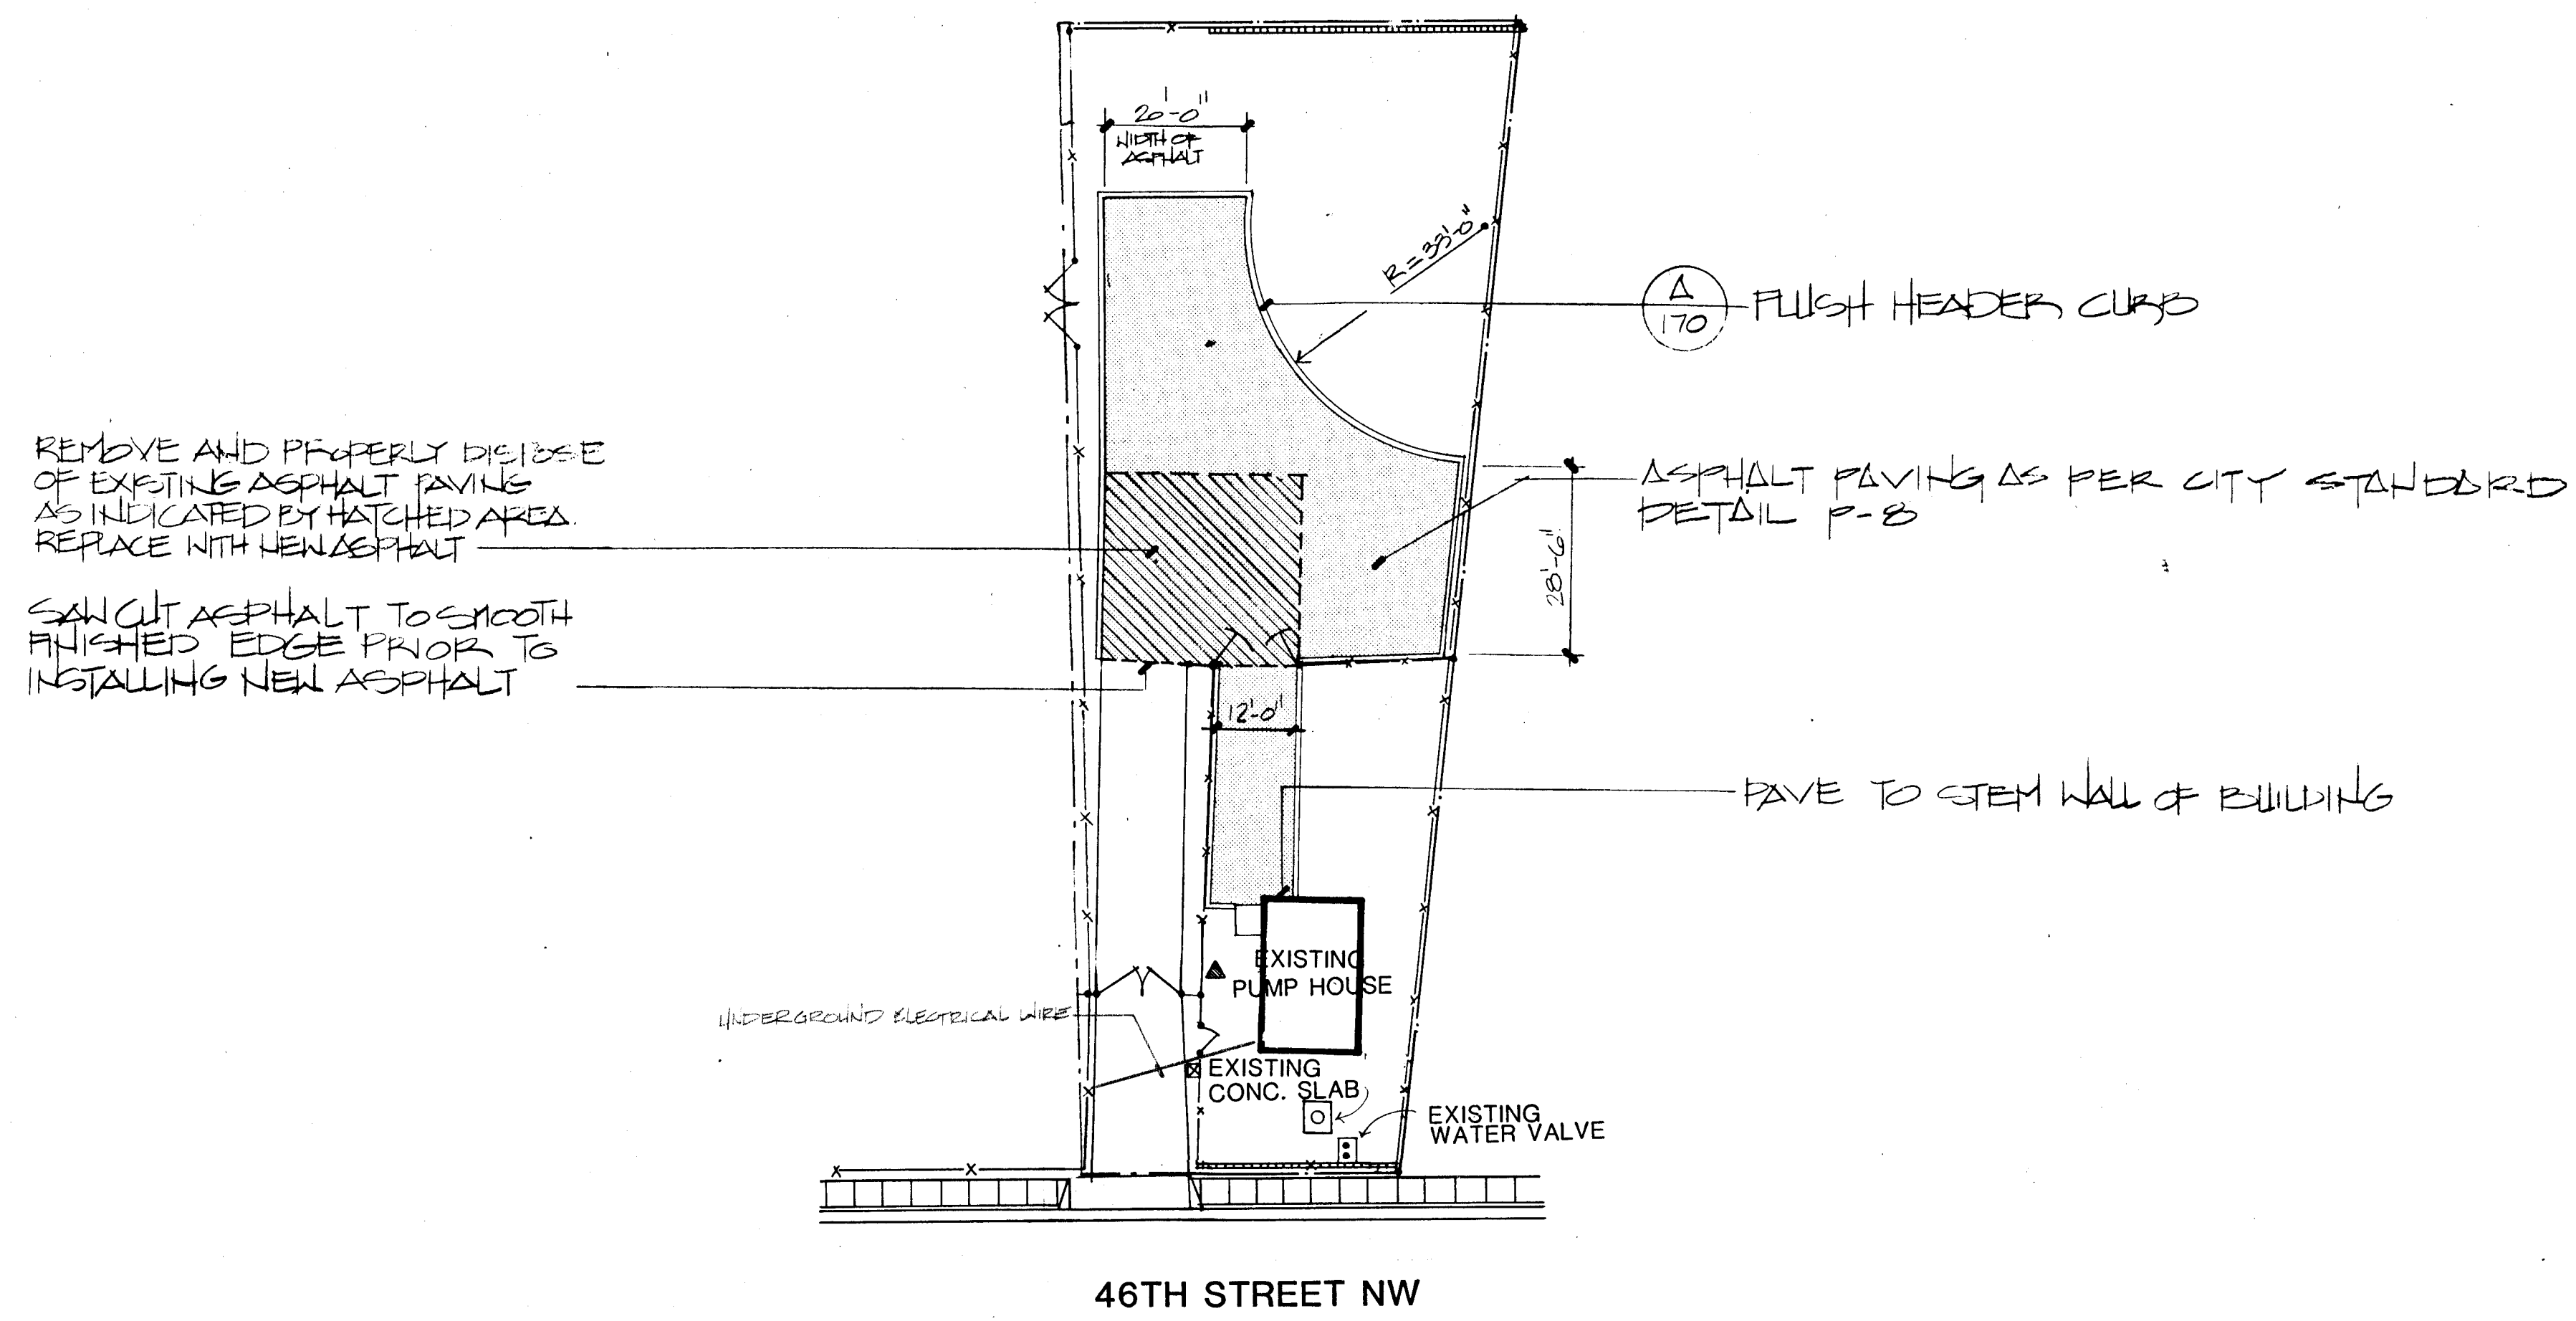


26 3097 0486

SCALE 1"=20'-0"

0 10 20 40

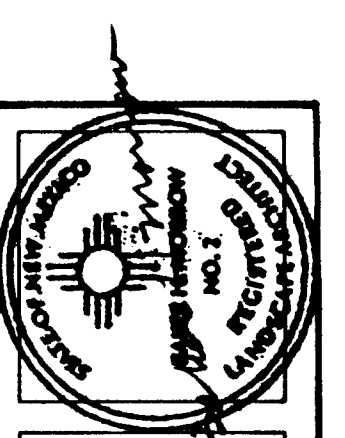

MORROW & COMPANY
LANDSCAPE ARCHITECTS
210 La Veta Drive NE
Albuquerque, New Mexico 87108
505-268-2266

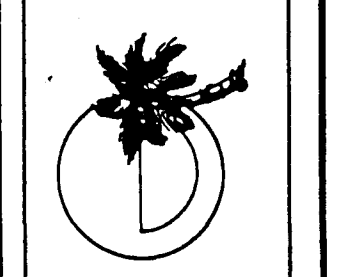


NOVEMBER
1986

AS BUILT
CONSTRUCTION PLAN
DEMOLITION PLAN /
ATRISCO WELL #3
324 46TH ST. NE

LANDSCAPING IMPROVEMENTS FOR
WATER SYSTEM FACILITY SITES
WATER SYSTEMS DIVISION
CITY OF ALBUQUERQUE
ALBUQUERQUE, NEW MEXICO

SHEET
4
172

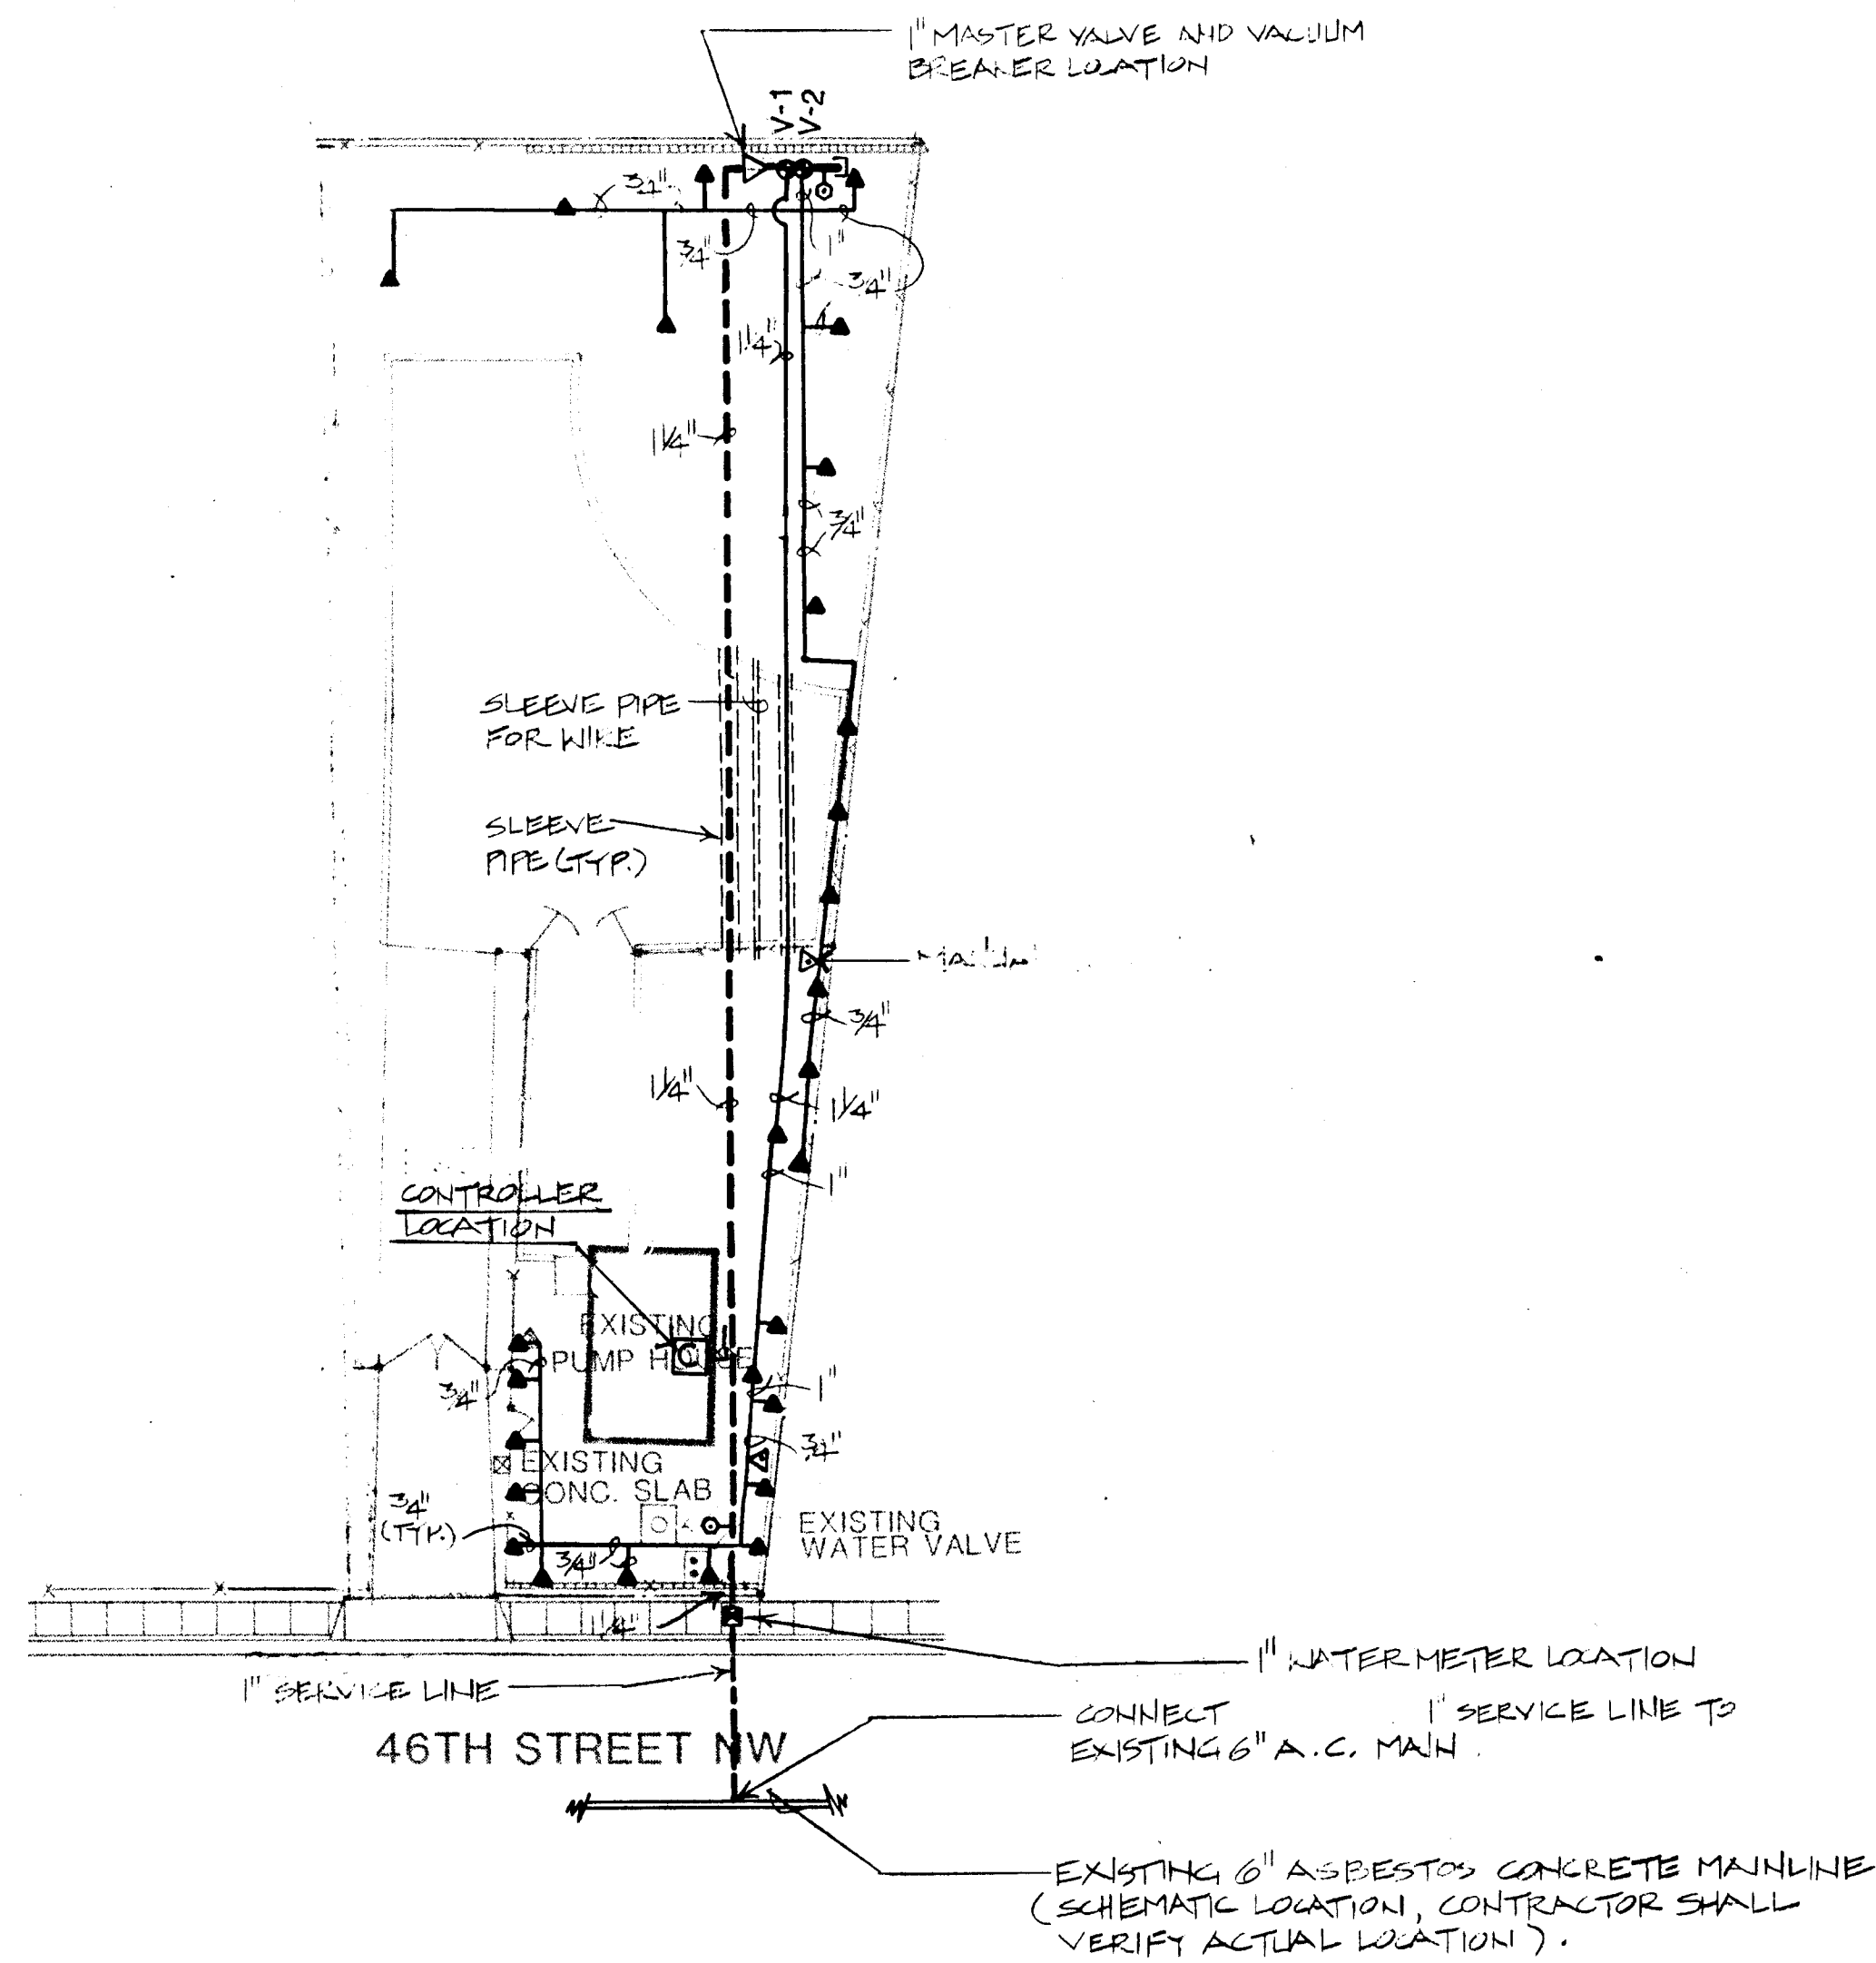

ELECTRICAL PANEL

IRRIGATION CONTROLLER



CIRCUIT # 9

3/4" RIGID STEEL CONDUIT, 110 VOLT CIRCUIT
1 1/2" RIGID STEEL CONDUIT, 24 VOLT CIRCUITS
TO REMOTE CONTROL VALVES

SCHEMATIC ASBUILT FOR 110 VOLT ELECTRICAL
FROM SOURCE TO IRRIGATION CONTROLLER

26 3097 0586

SCALE 1"=20'-0"

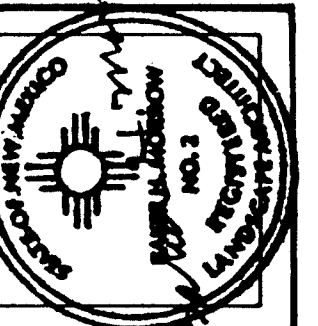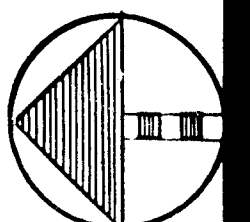

MORROW & COMPANY
LANDSCAPE ARCHITECTS
210 La Veta Drive NE
Albuquerque, New Mexico 87108
505-268-2266



NOVEMBER
1986

AS BUILT


ATRISCO WELL #3
324 46TH ST. NE

IRRIGATION PLAN

LANDSCAPING IMPROVEMENTS FOR
WATER SYSTEM FACILITY SITES
WATER SYSTEMS DIVISION
CITY OF ALBUQUERQUE
ALBUQUERQUE, NEW MEXICO

SHEET

172

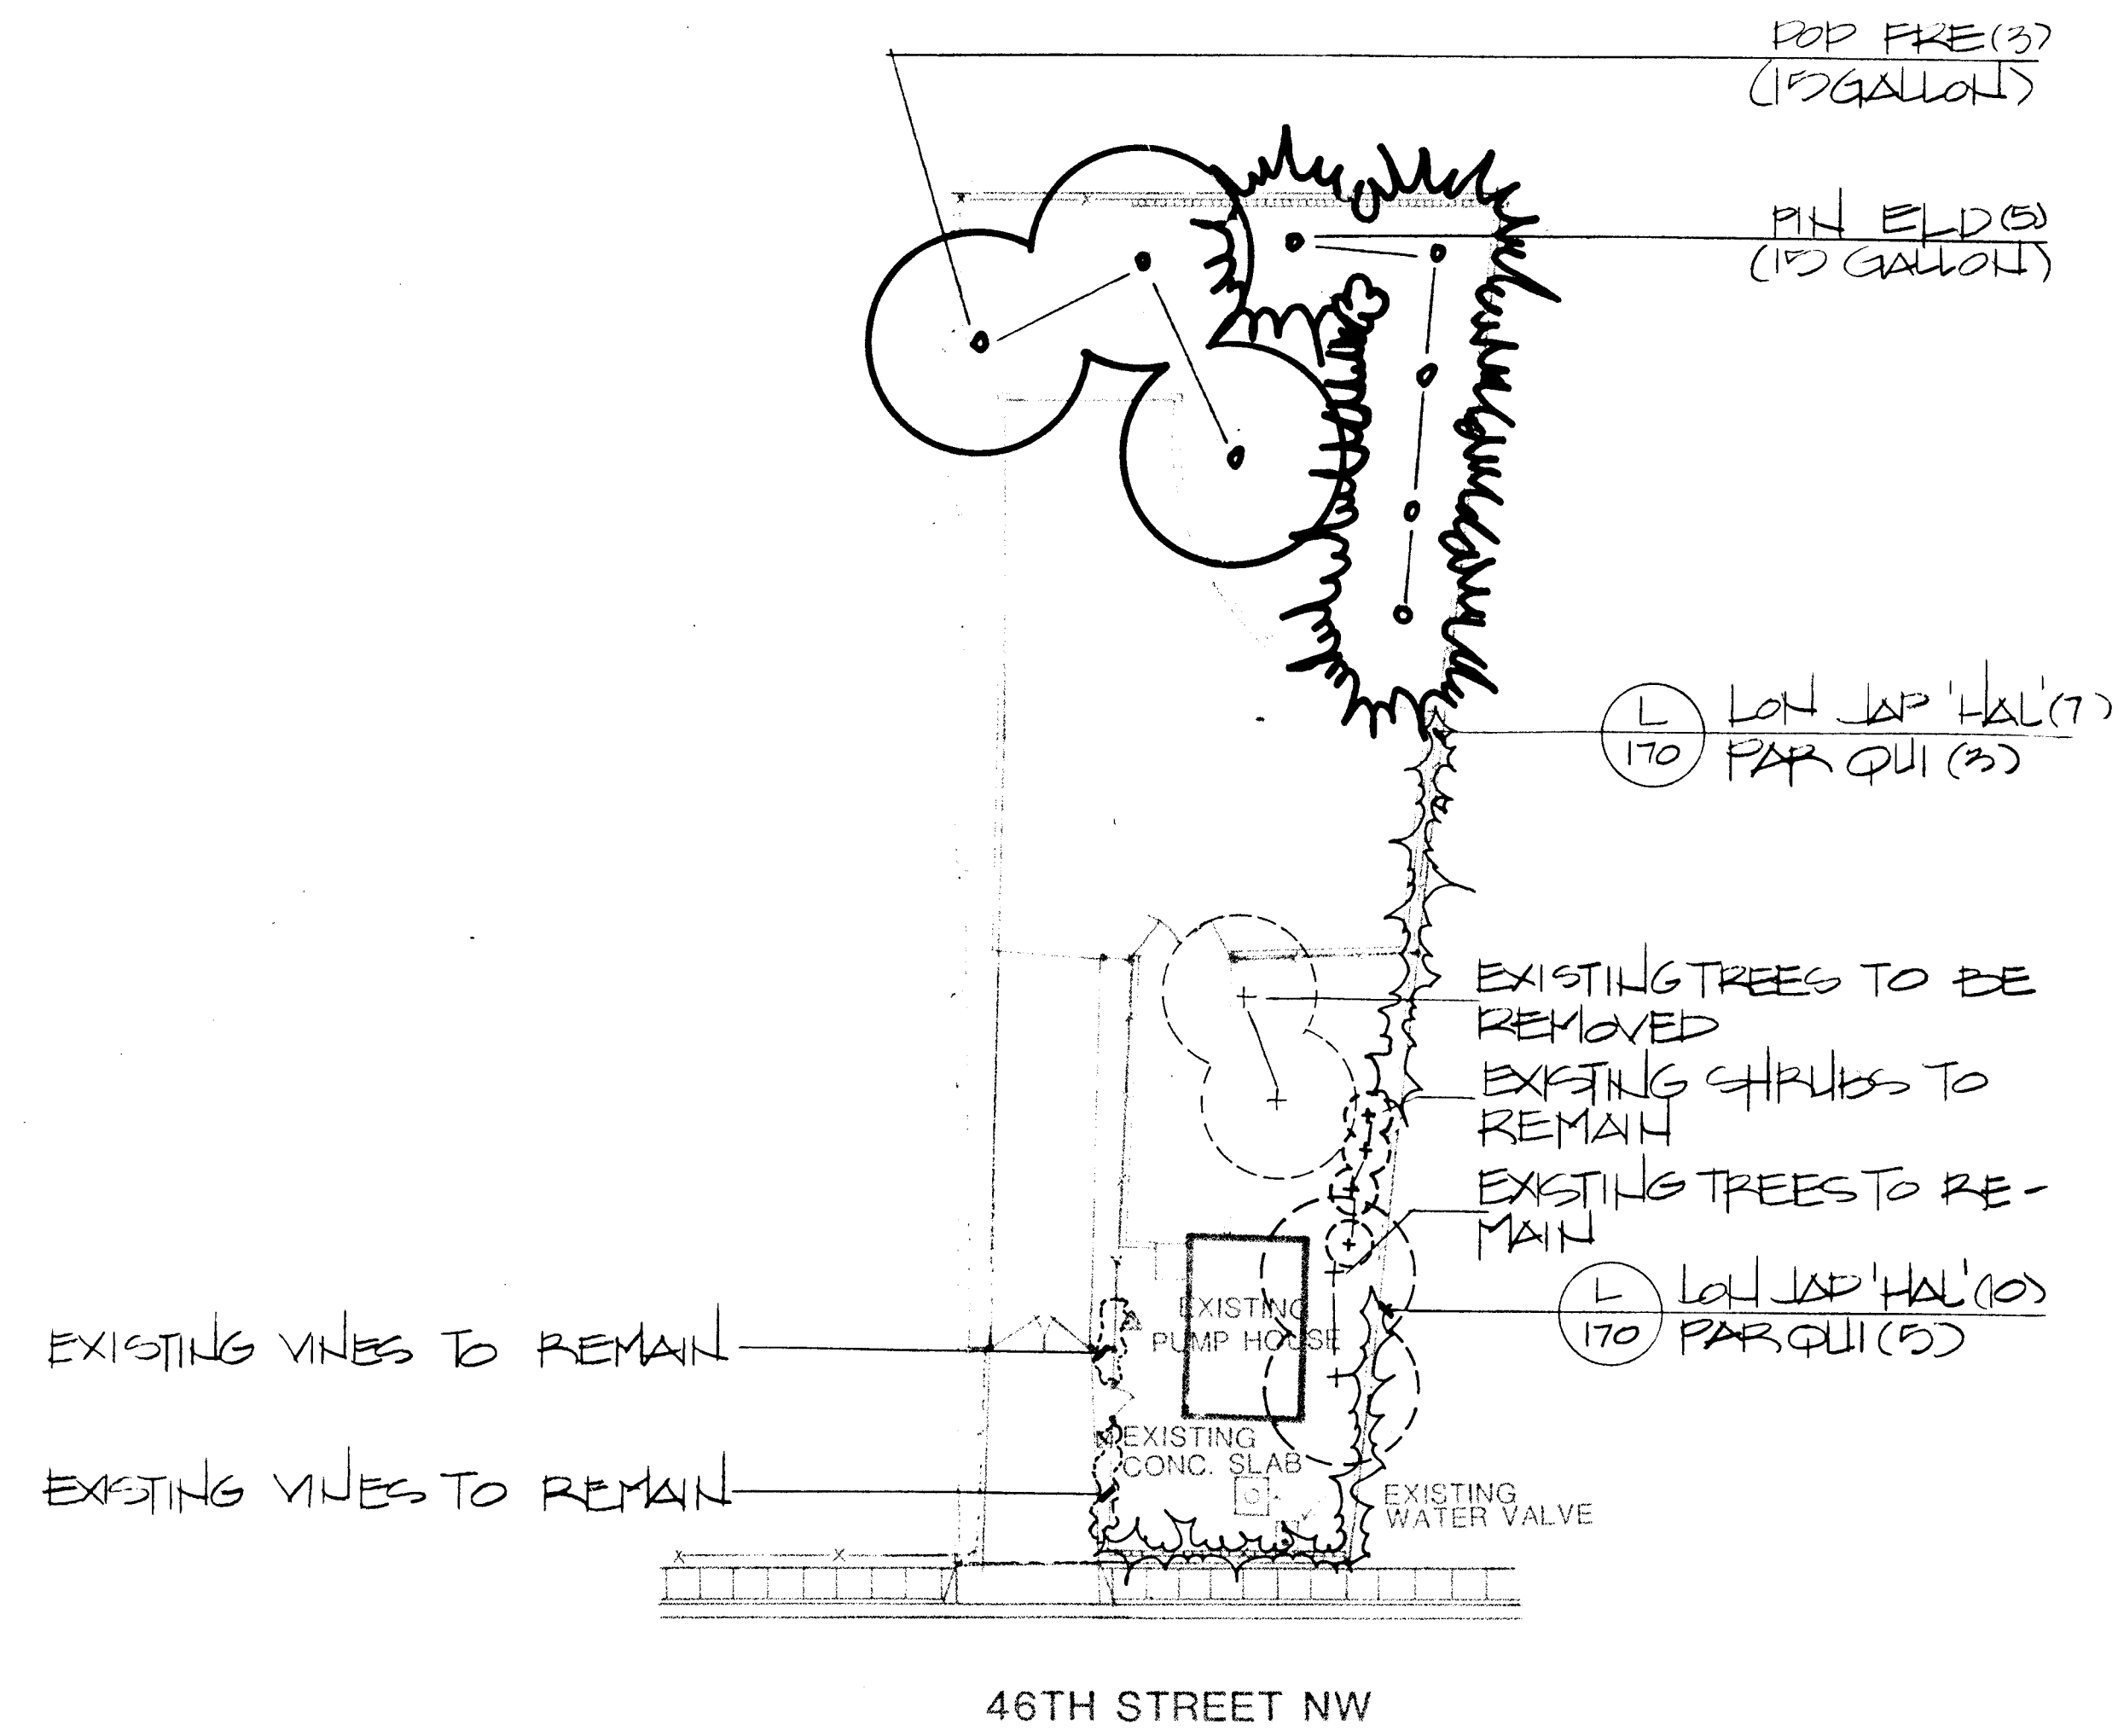

SCALE 1"=20'-0"

0 10 20 40

26 30 97 06 86

SHEET

172


LANDSCAPING IMPROVEMENTS FOR
WATER SYSTEM FACILITY SITES
WATER SYSTEMS DIVISION
CITY OF ALBUQUERQUE
ALBUQUERQUE, NEW MEXICO


ATRISCO WELL #3
324 46TH ST. NE
PLANTING PLAN

AS BUILT

NOVEMBER
1986


MORROW & COMPANY
LANDSCAPE ARCHITECTS
210 La Veta Drive NE
Albuquerque, New Mexico 87108
505-268-2266

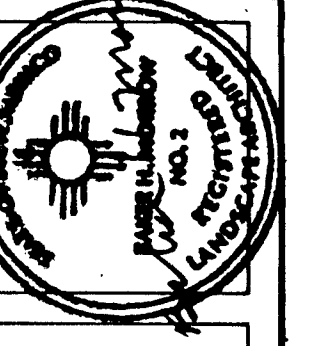

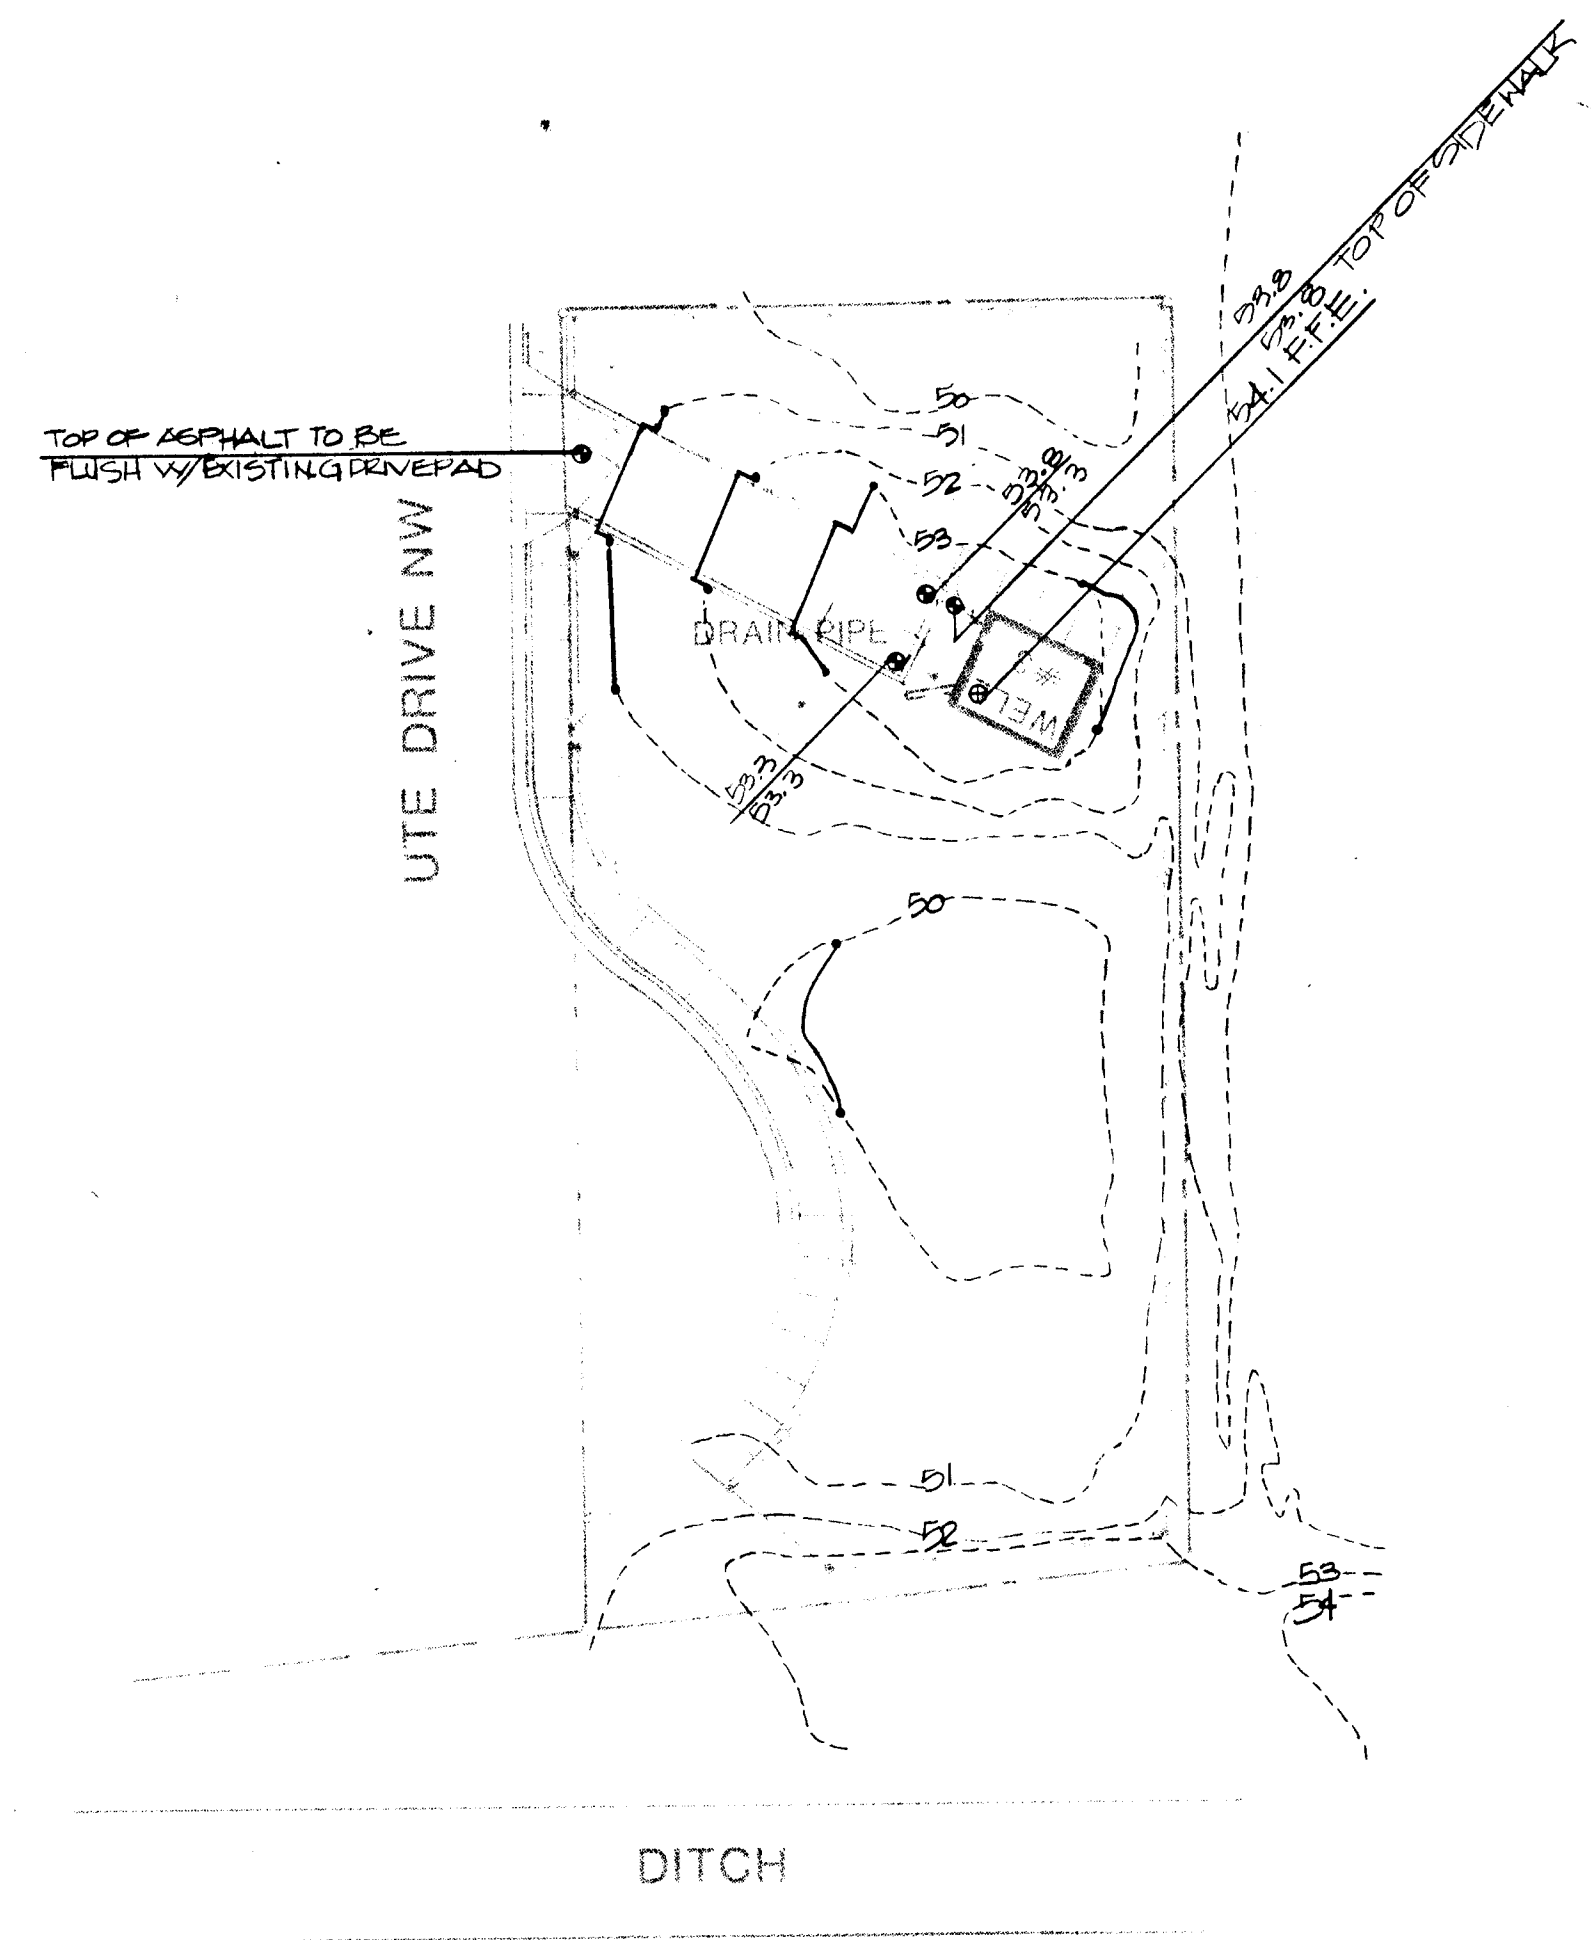

26 30.97 0786

SCALE 1"=20'-0"

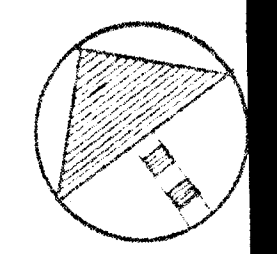

MORROW & COMPANY
LANDSCAPE ARCHITECTS
210 La Veta Drive NE
Albuquerque, New Mexico 87108
505-268-2266



NOVEMBER
1986

AS BUILT


ATRISCO WELL #4
5029 UTE Dr. NW
GRADING PLAN

LANDSCAPING IMPROVEMENTS FOR
WATER SYSTEM FACILITY SITES
WATER SYSTEMS DIVISION
CITY OF ALBUQUERQUE
ALBUQUERQUE, NEW MEXICO

SHEET
7
OF
172


NOTES:

1. EXISTING FENCE TO BE REMOVED AND RELOCATED AS SHOWN.
2. INSTALL NEW CHAINLINK FENCE AS NEEDED TO CONNECT RELOCATED FENCE TO EXISTING FENCE.

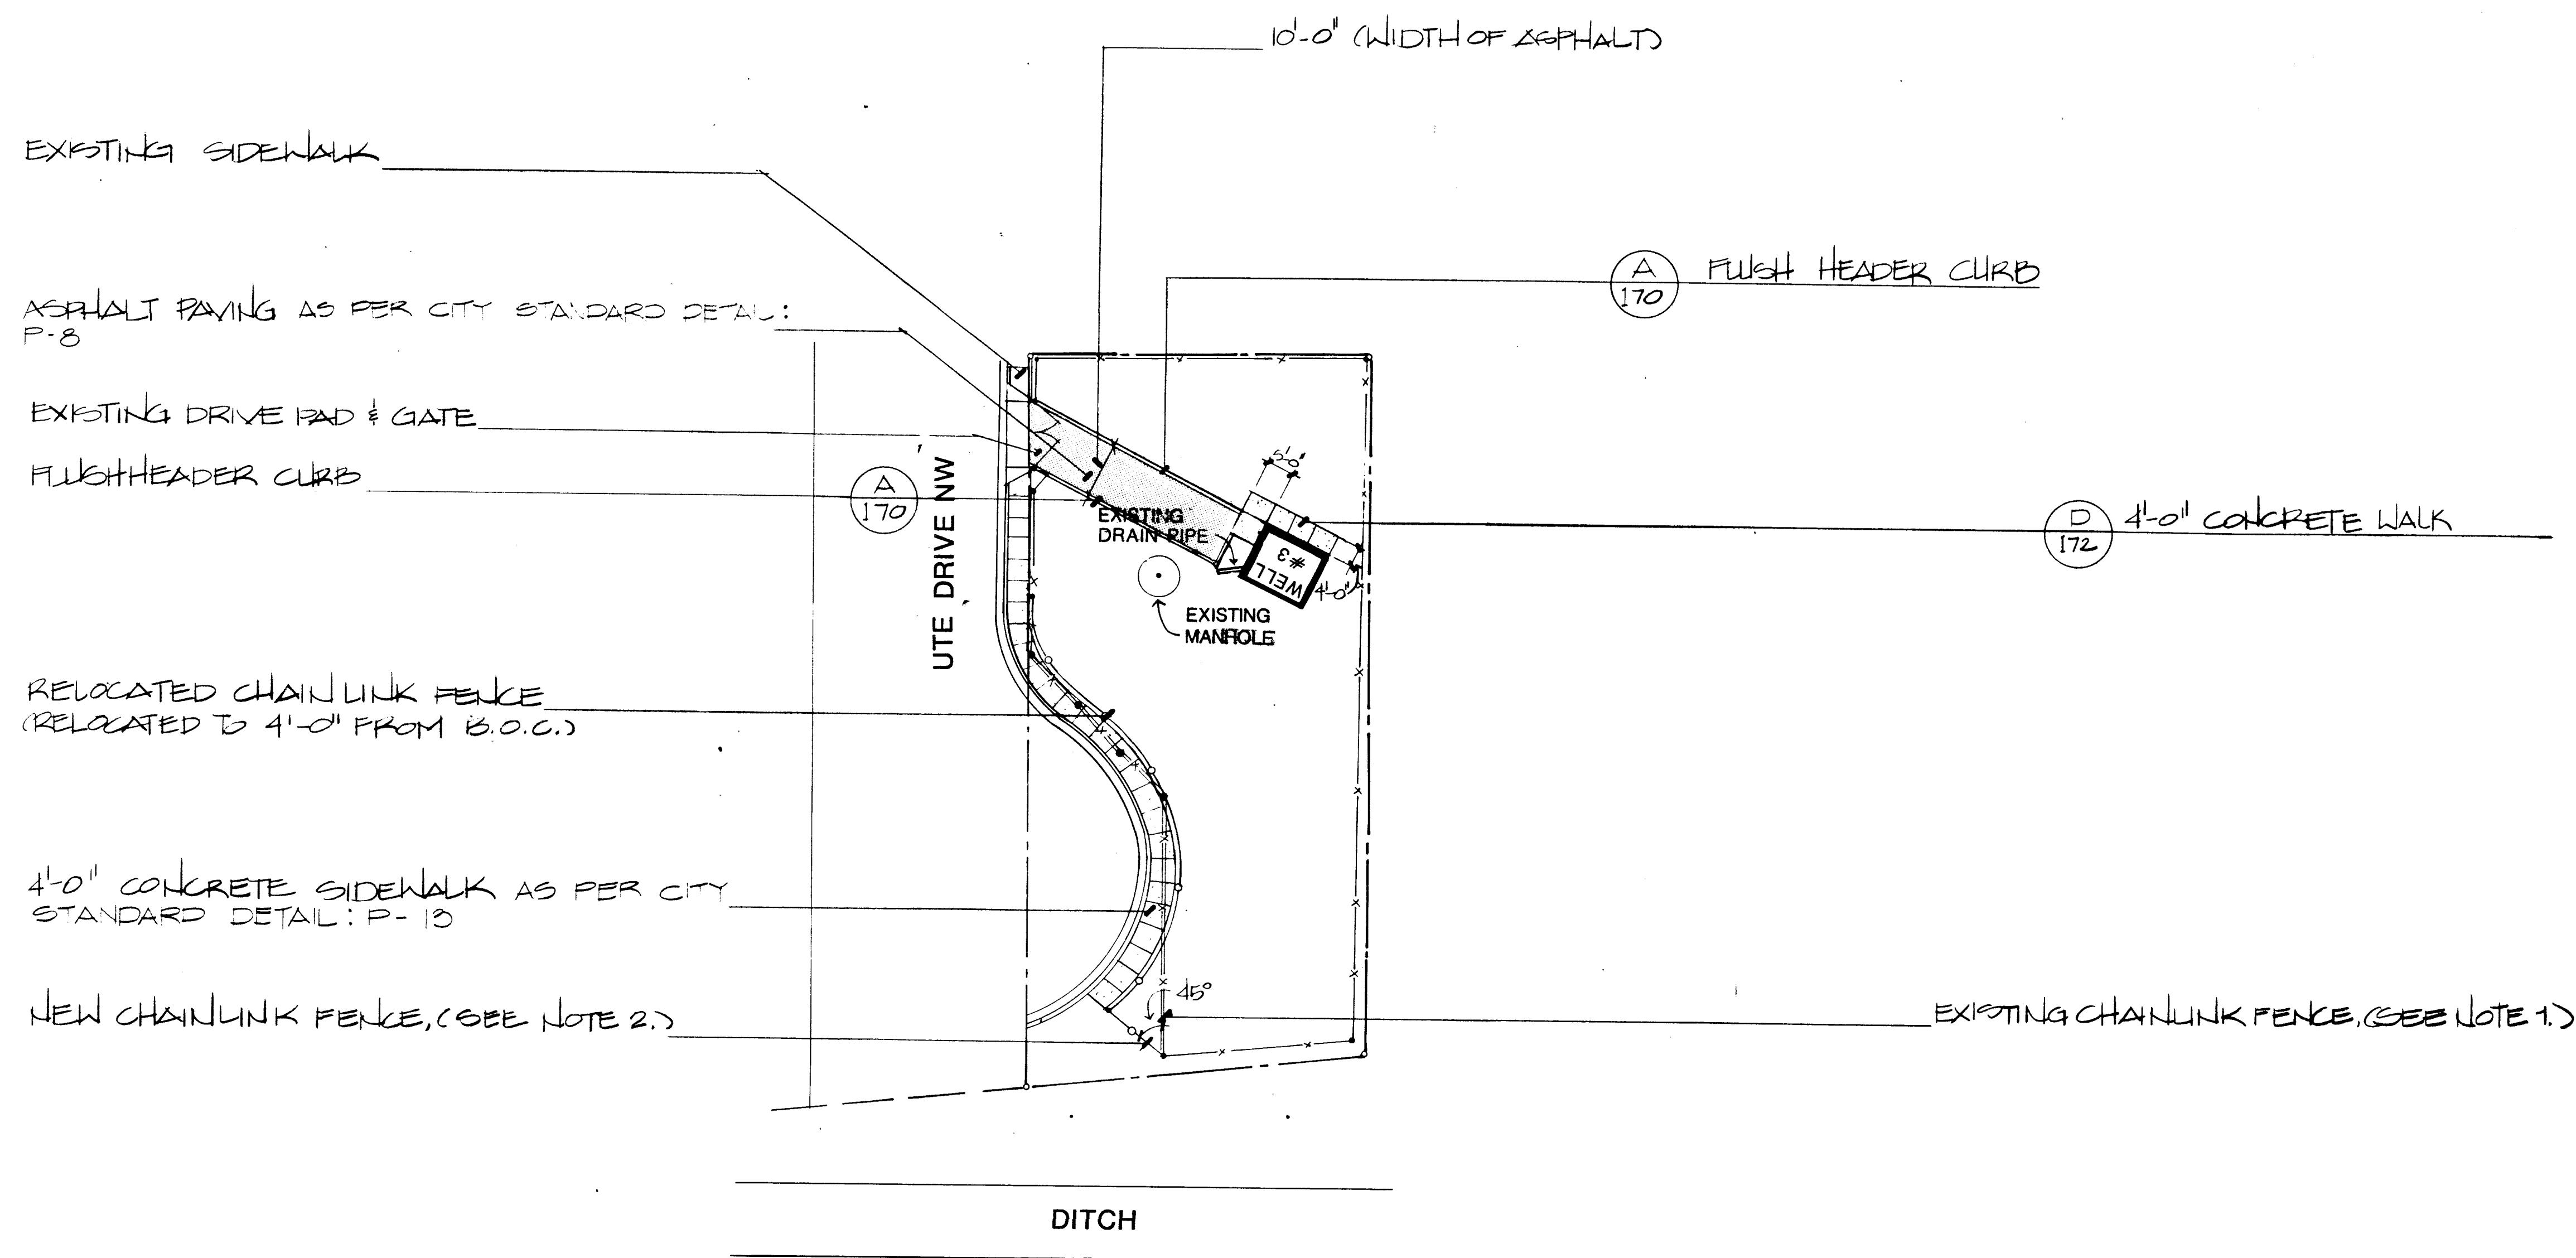

26 3097 0886

SCALE 1"=20'-0"

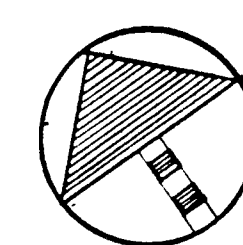

MORROW & COMPANY
LANDSCAPE ARCHITECTS
210 La Veta Drive NE
Albuquerque, New Mexico 87108
505-268-2266


NOVEMBER 1986

AS BUILT

ATRISCO WELL #4
5029 UTE Dr. NW
CONSTRUCTION PLAN



LANDSCAPING IMPROVEMENTS FOR
WATER SYSTEM FACILITY SITES
WATER SYSTEMS DIVISION
CITY OF ALBUQUERQUE
ALBUQUERQUE, NEW MEXICO

SHEET
8
OF
172

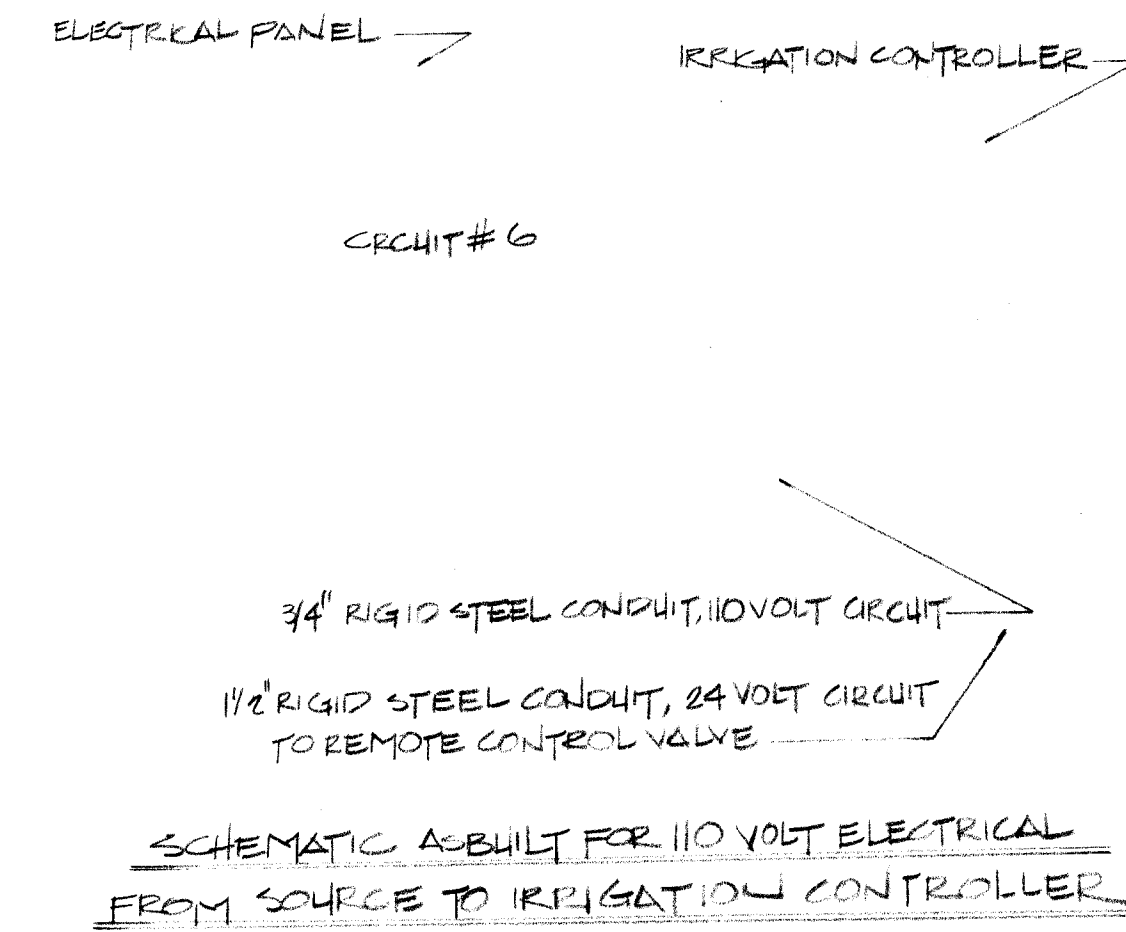


2	3	4	5	6	7	8	9	10	11	12
26	30	97	09	86						

SCALE 1"=20'-0"

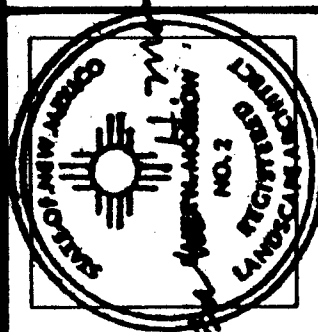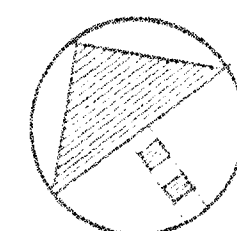

MORROW & COMPANY
LANDSCAPE ARCHITECTS
210 La Veta Drive NE
Albuquerque, New Mexico 87108
505-268-2266

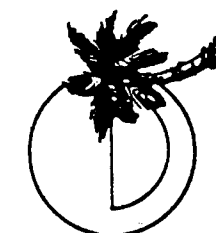
NOVEMBER
1986

AS BUILT

ATRISCO WELL #4
5029 UTE Dr. NW
IRRIGATION PLAN



**LANDSCAPING IMPROVEMENTS FOR
WATER SYSTEM FACILITY SITES**
WATER SYSTEMS DIVISION
CITY OF ALBUQUERQUE
ALBUQUERQUE, NEW MEXICO

SHEET
9
OF
172

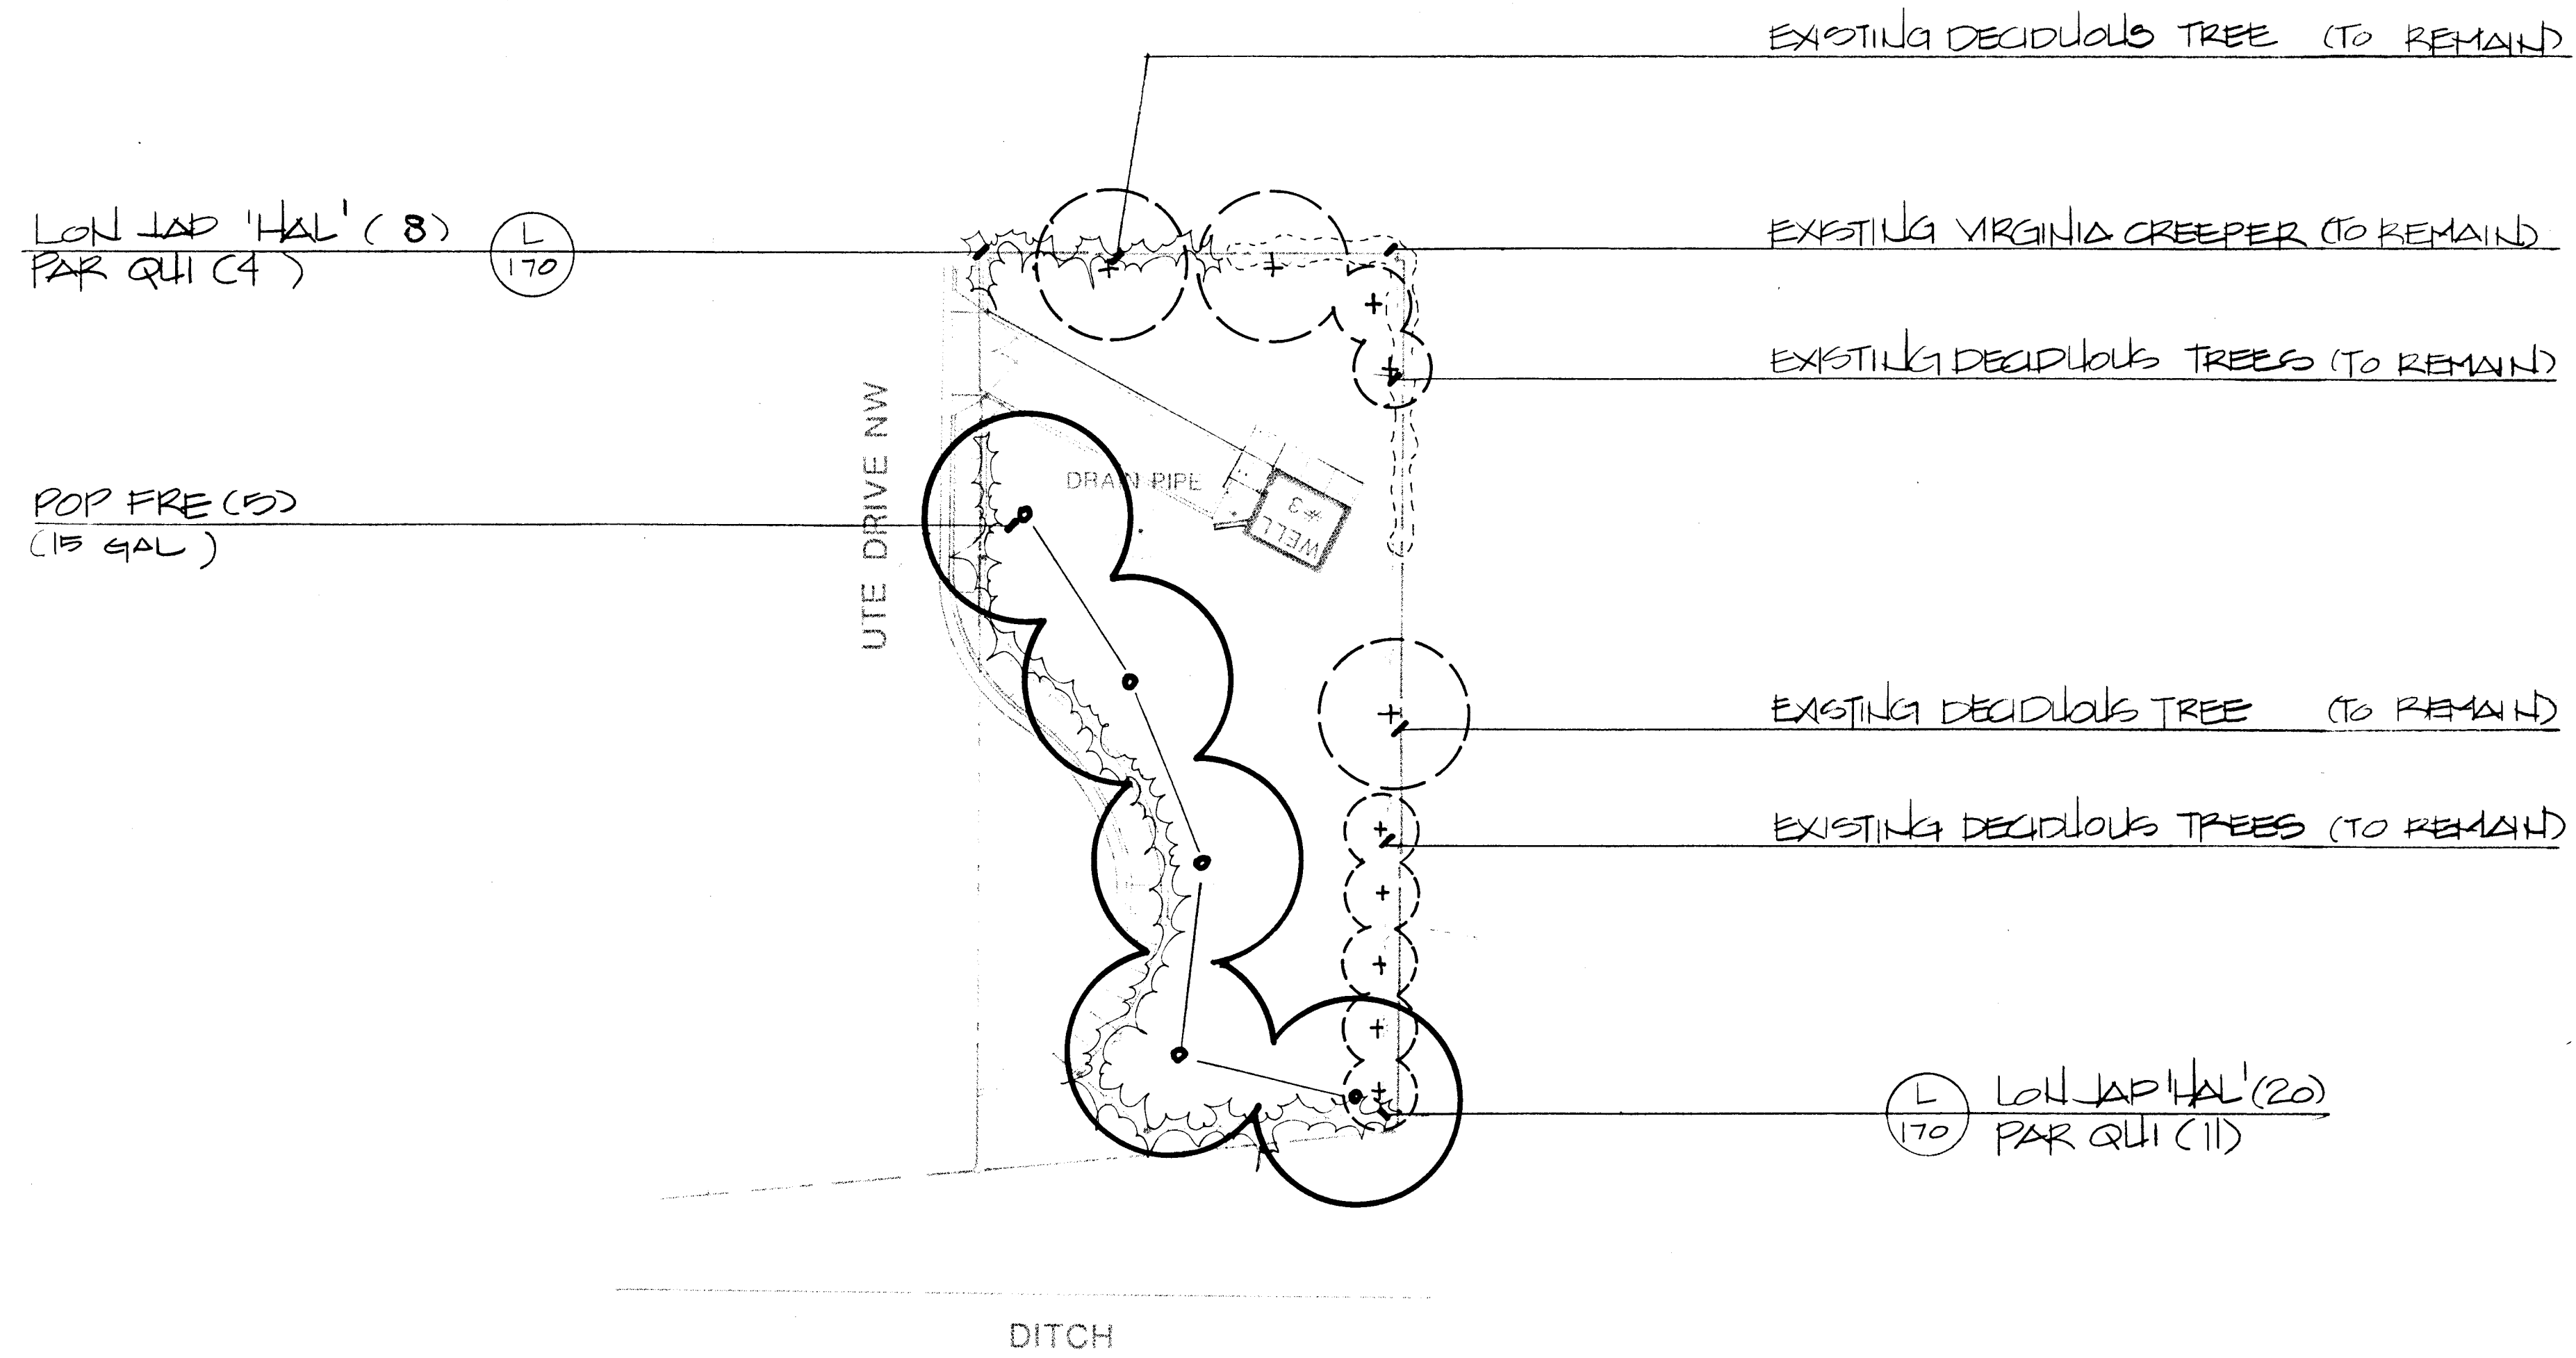


26 3097 1086

SCALE 1"=20'-0"

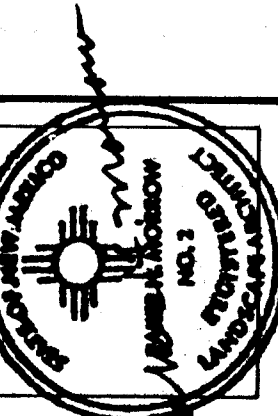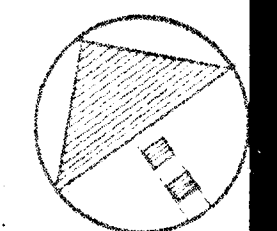

MORROW & COMPANY
 LANDSCAPE ARCHITECTS
 210 La Veta Drive NE
 Albuquerque, New Mexico 87108
 505-268-2266

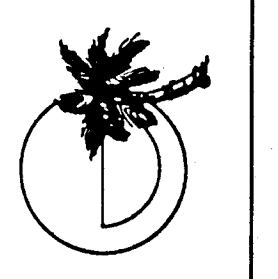

NOVEMBER
 1986

AS BUILT

ATRISCO WELL #4
 5029 UTE Dr. NW
 PLANTING PLAN

LANDSCAPING IMPROVEMENTS FOR
WATER SYSTEM FACILITY SITES
 WATER SYSTEMS DIVISION
 CITY OF ALBUQUERQUE
 ALBUQUERQUE, NEW MEXICO

SHEET
 10
 172

SAN RAFAEL AVE. SE

CARLISLE AVE. SE

BURTON PARK

KATHRYN AVE. SE

WELL HOUSE

TURF
BLOCK

PATTERNED
CONCRETE

RESERVOIR

RESERVOIR

2" MASTER VALVE AND
VACUUM BREAKER LOCATION.

SEE SHEET 12
FOR CONTINUATION OF
IRRIGATION.

EXISTING 14" C.I. MAINLINE
(LOCATION IS SCHEMATIC.
CONTRACTOR SHALL VERIFY
ACTUAL LOCATION).

2" WATER METER LOCATION


2" SERVICE LINE

CONNECT

2" SERVICE LINE TO EXISTING 14" CAST IRON MAIN.

SCALE 1"=20'-0"

0 10 20 40

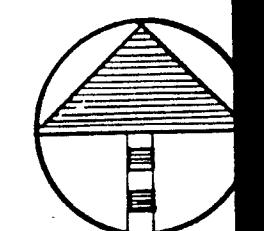

MORROW & COMPANY
LANDSCAPE ARCHITECTS
210 La Veta Drive NE
Albuquerque, New Mexico 87108
505-268-2266

NOVEMBER
1986

BURTON RESERVOIR #1 & #2 & PUMP STATION
1200 WELLESLEY DR. SE
IRRIGATION PLAN


AS BUILT

LANDSCAPING IMPROVEMENTS FOR
WATER SYSTEM FACILITY SITES
WATER SYSTEMS DIVISION
CITY OF ALBUQUERQUE
ALBUQUERQUE, NEW MEXICO

SHEET
172

26 3097 1186

WELLESLEY DR. SE

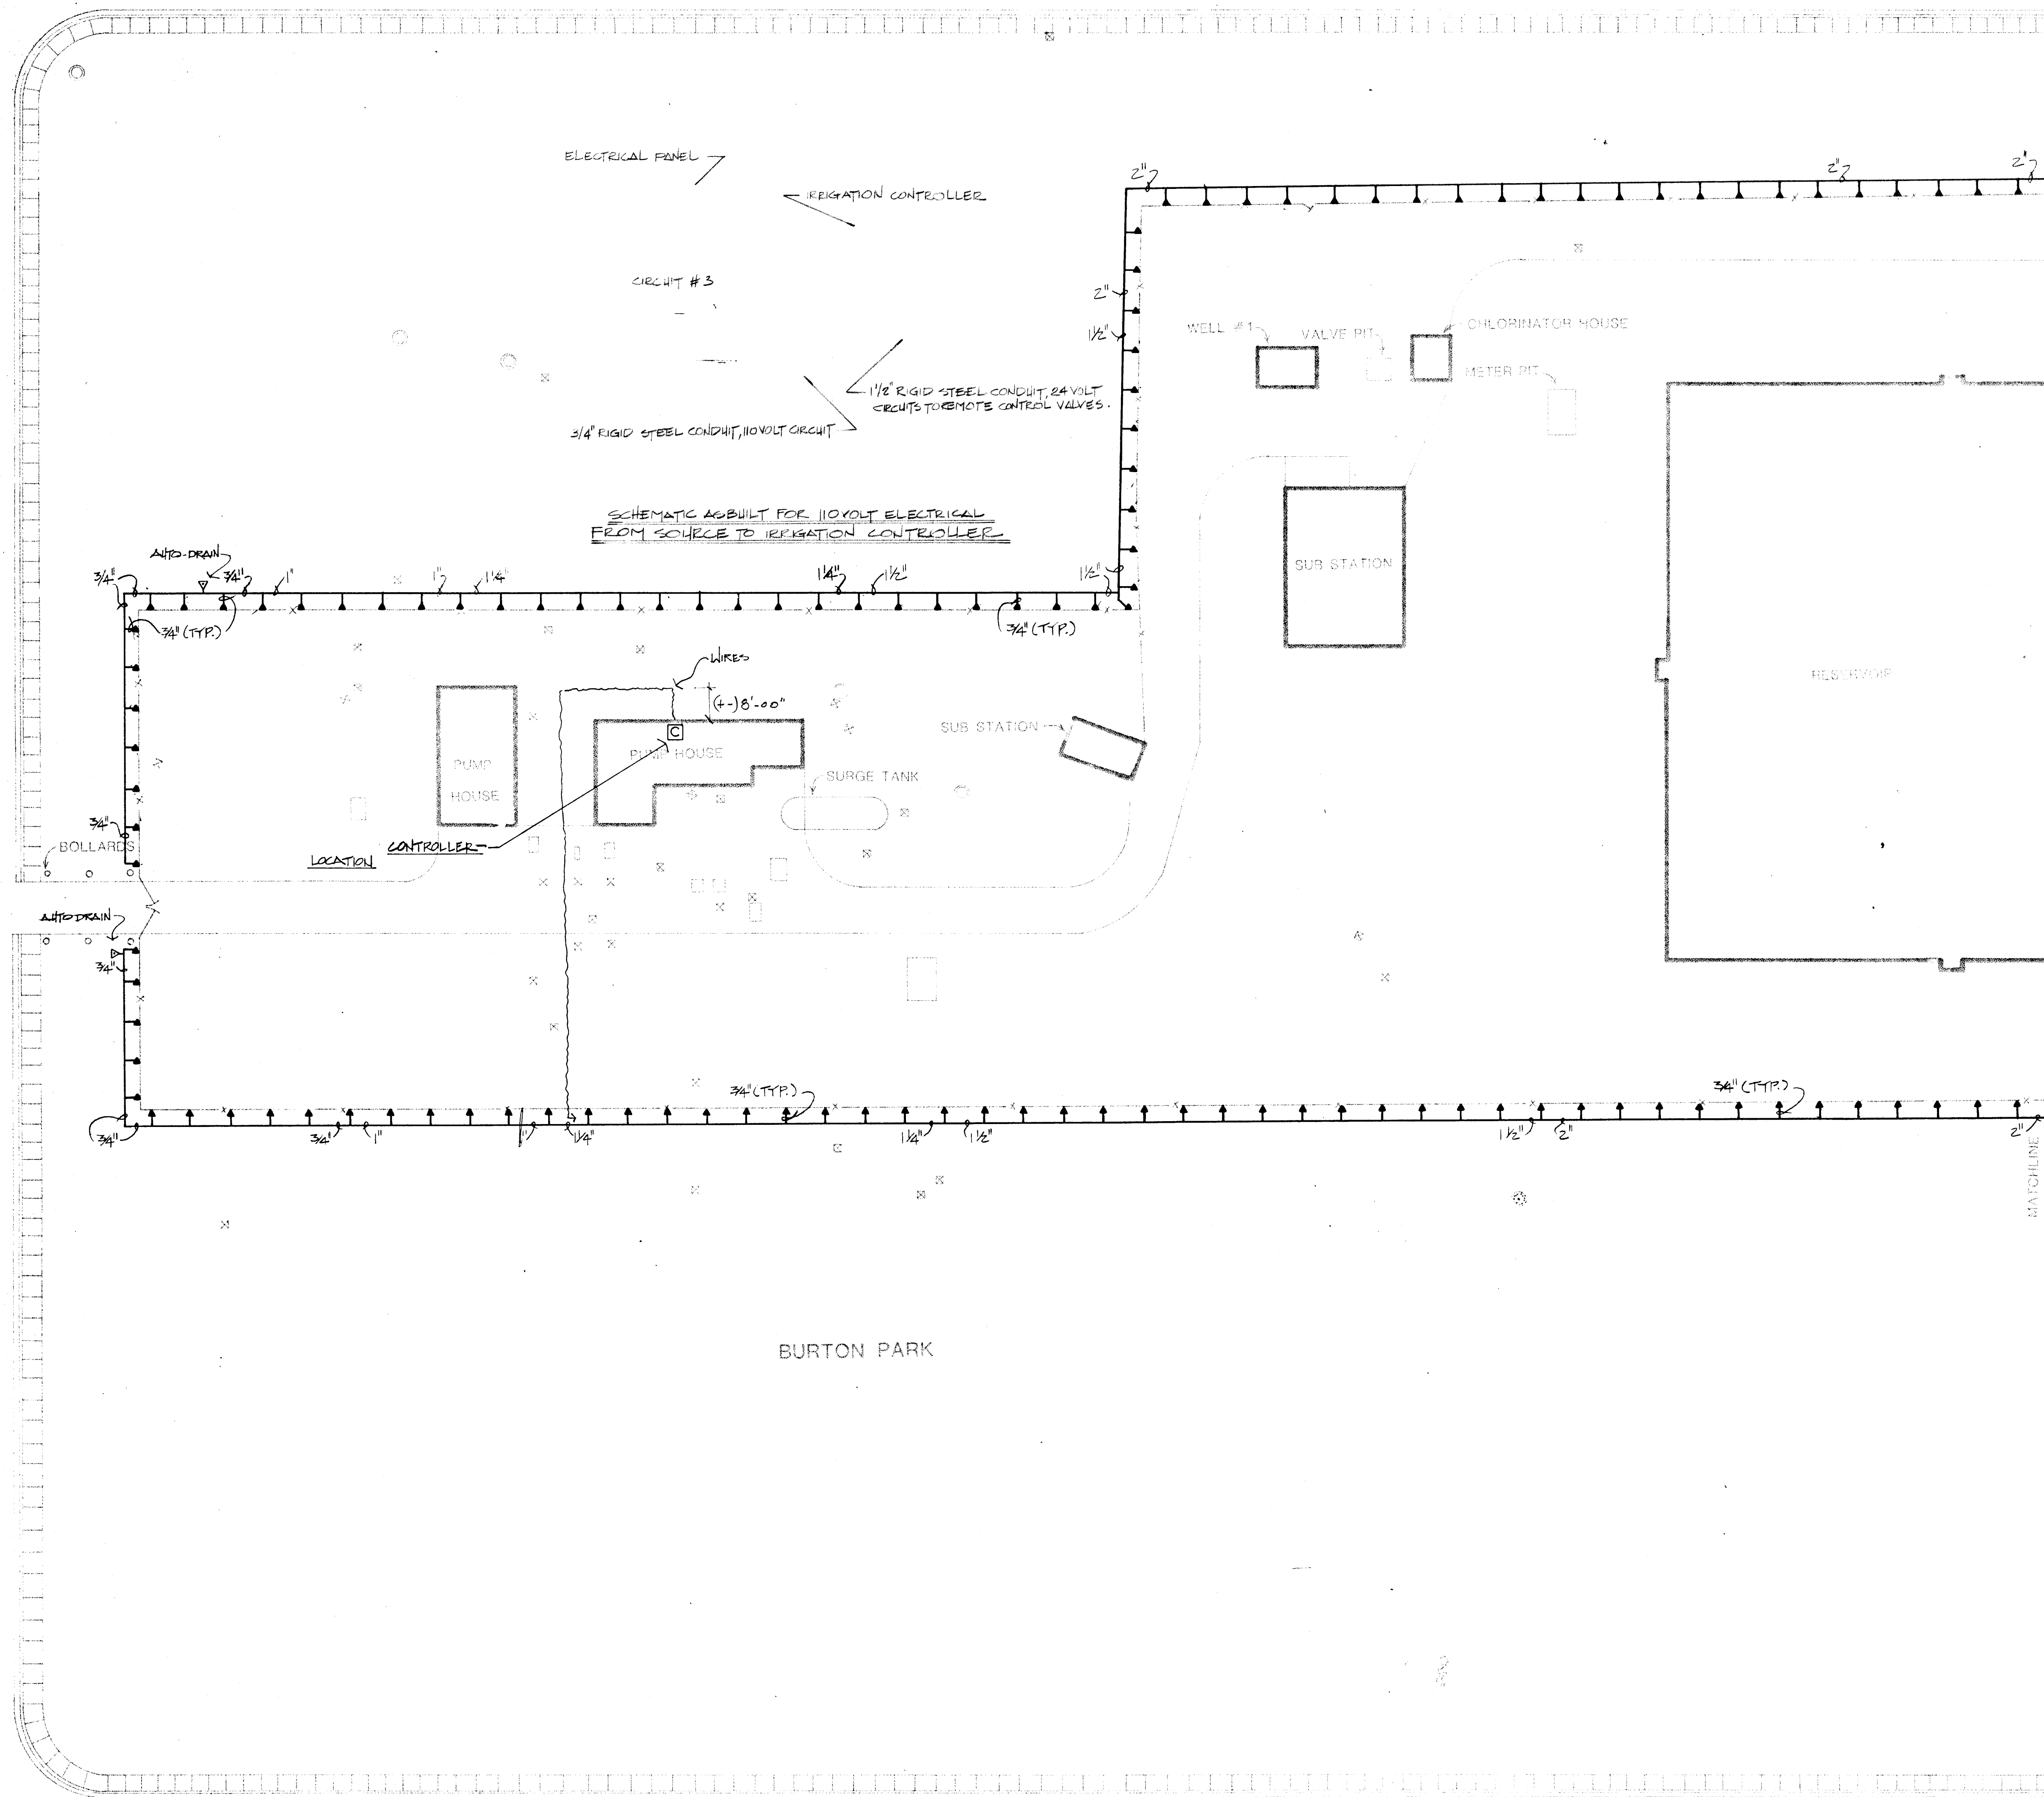

SEE SHEET 11
FOR CONTINUATION OF IRRIGATION.


SEE SHEET 11
FOR CONTINUATION OF IRRIGATION.

BURTON PARK

KATHRYN AVE. SE

26 3097 1286

SCALE 1"=20'-0"

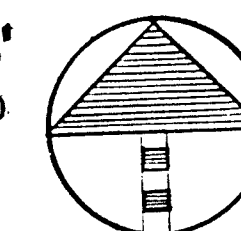

MORROW & COMPANY
LANDSCAPE ARCHITECTS
210 La Veta Drive NE
Albuquerque, New Mexico 87108
505-268-2266


NOVEMBER
1986

AS BUILT

BURTON RESERVOIR #1, #2 AND PUMP STATION
1200 WELLESLEY DR. SE
IRRIGATION PLAN

LANDSCAPING IMPROVEMENTS FOR
WATER SYSTEM FACILITY SITES
WATER SYSTEMS DIVISION
CITY OF ALBUQUERQUE
ALBUQUERQUE, NEW MEXICO

SHEET
12
97
172

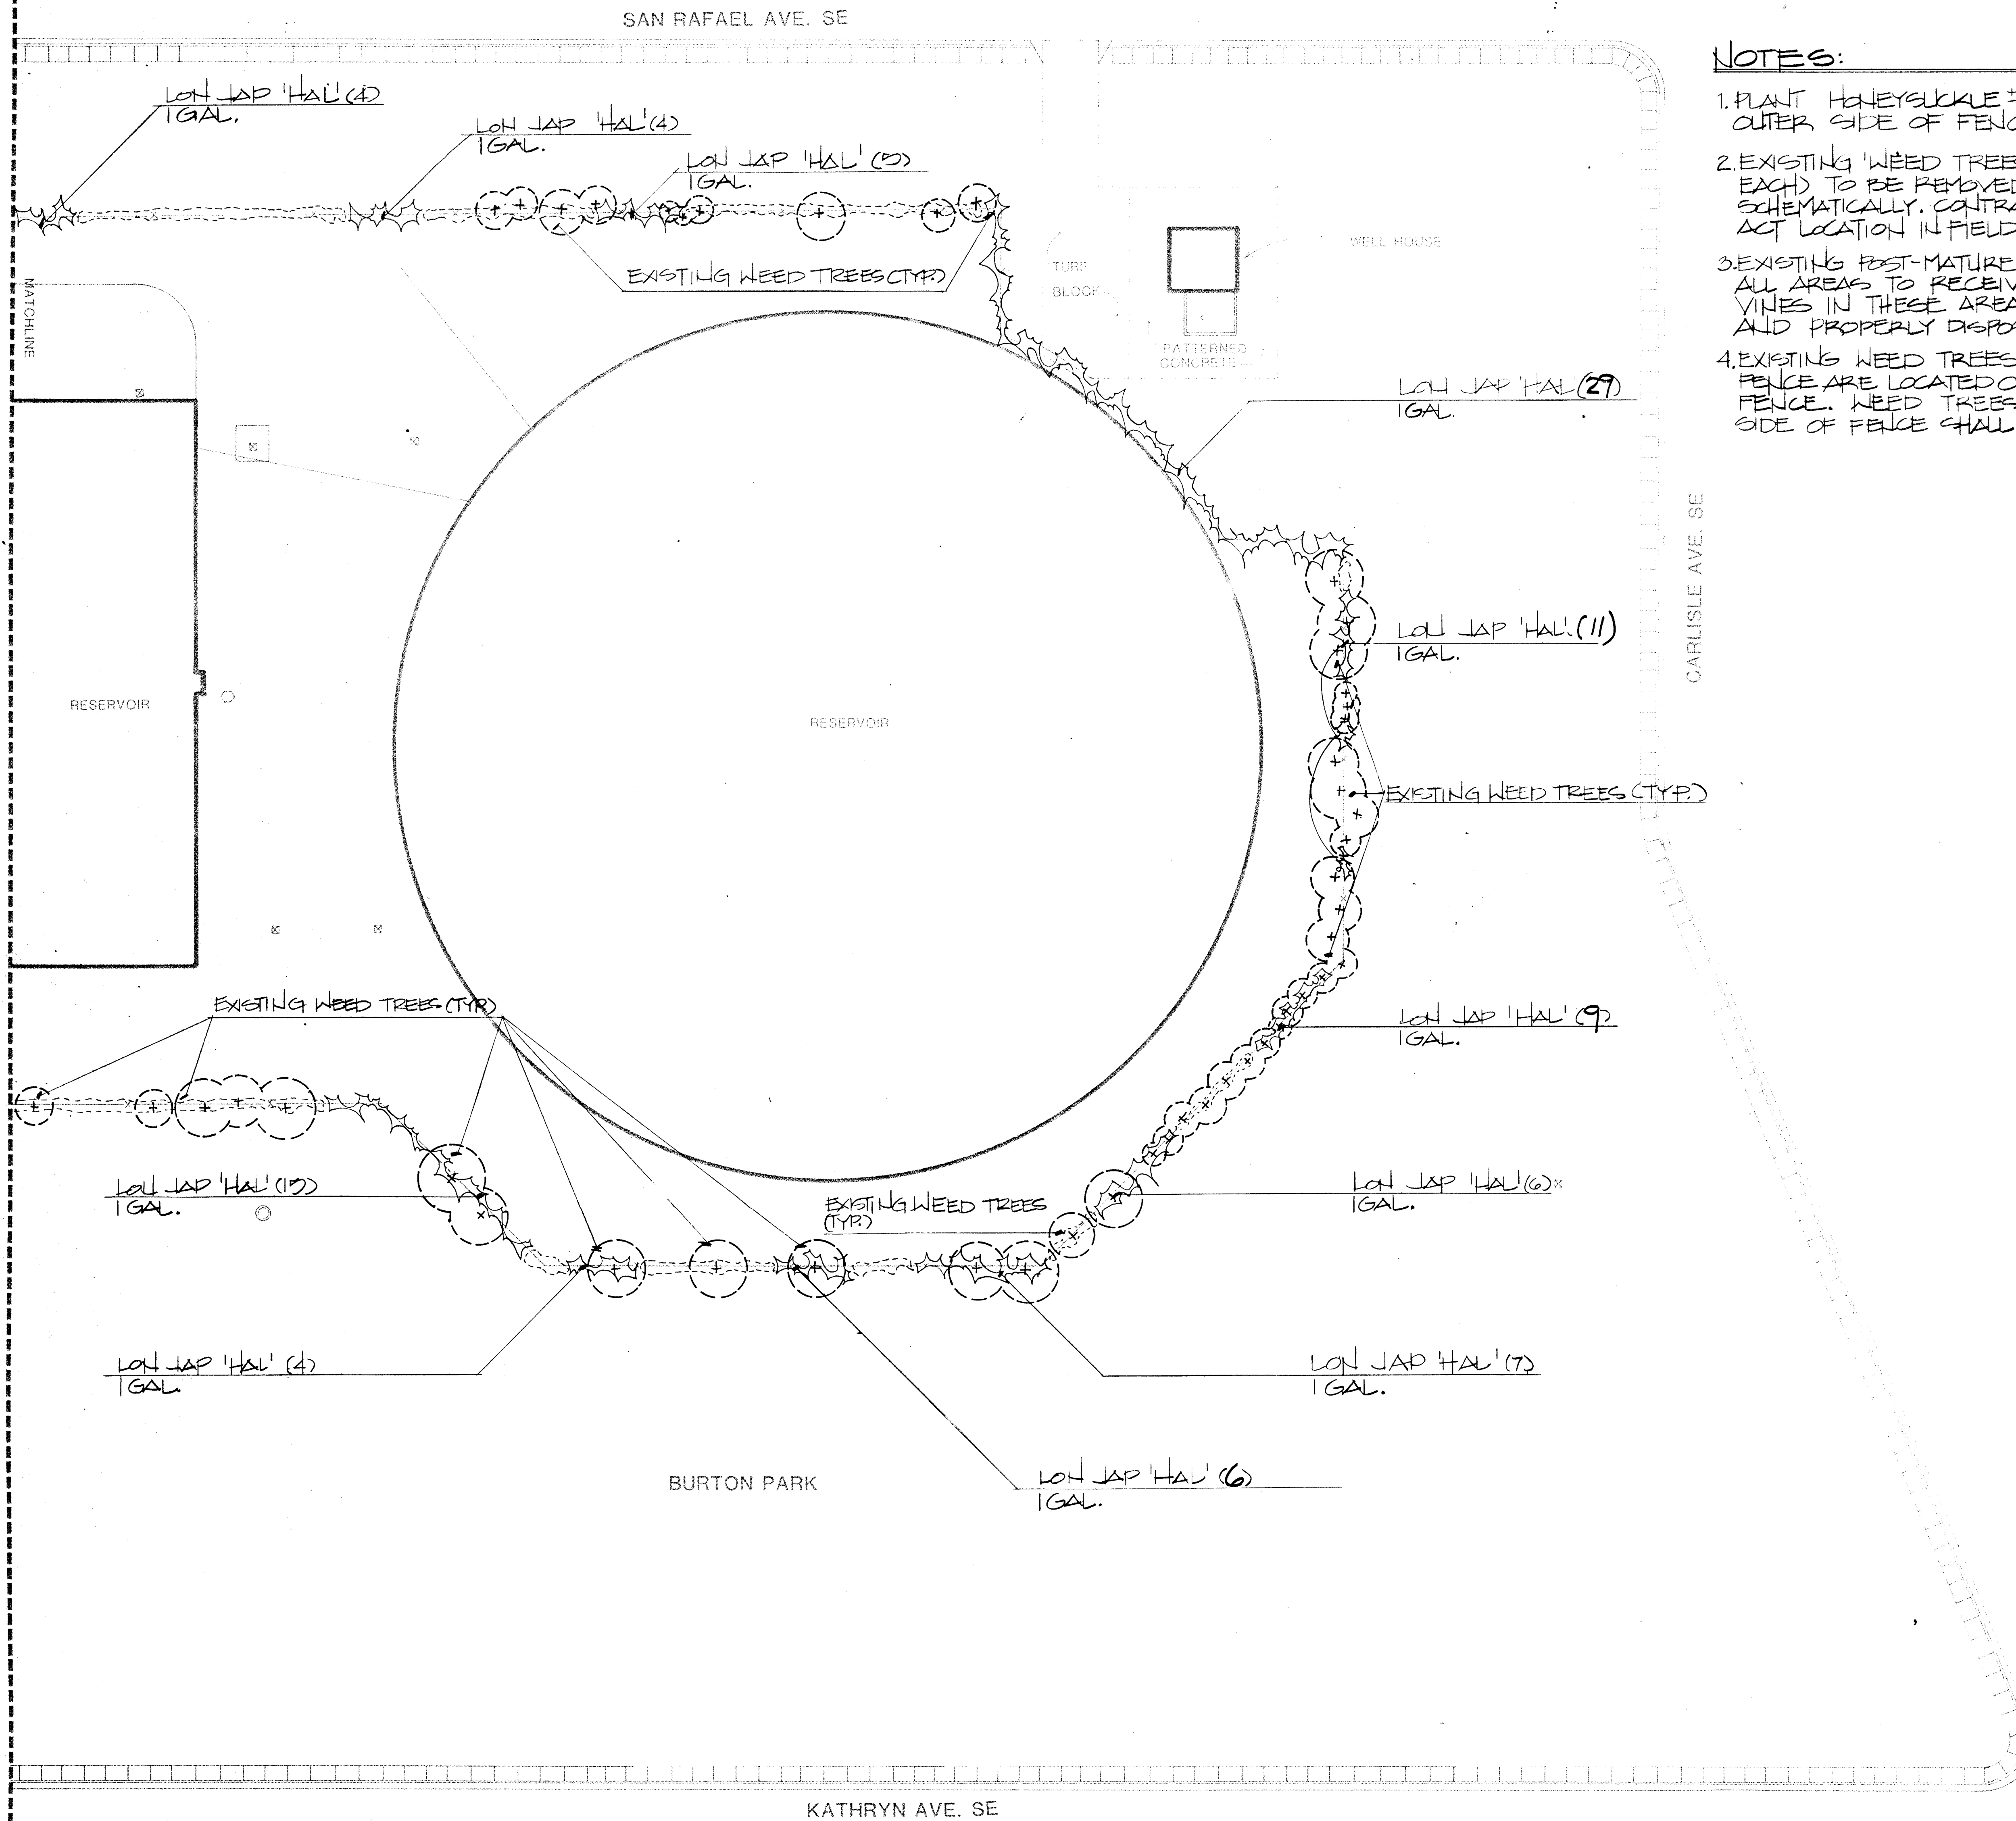

NOTES:

1. PLANT HONEYSUCKLE #12' FROM FENCE ALONG OUTER SIDE OF FENCE.
2. EXISTING 'WEED TREES' (APPROXIMATELY 125 EACH) TO BE REMOVED AT FENCE ARE SHOWN SCHEMATICALLY. CONTRACTOR SHALL VERIFY EXACT LOCATION IN FIELD. SEE NOTE #4.
3. EXISTING POST-MATURE VINES ARE LOCATED IN ALL AREAS TO RECEIVE NEW VINES. EXISTING VINES IN THESE AREAS SHALL BE REMOVED AND PROPERLY DISPOSED OF.
4. EXISTING WEED TREES TO BE REMOVED AT FENCE ARE LOCATED ON BOTH SIDES OF THE FENCE. WEED TREES WITHIN 15'-0" OF EITHER SIDE OF FENCE SHALL BE REMOVED.

26 3097 1386
SCALE 1"=20'-0"
0 10 20 40


MORROW & COMPANY
LANDSCAPE ARCHITECTS
210 La Veta Drive NE
Albuquerque, New Mexico 87108
505-268-2266

NOVEMBER 1986

BURTON RESERVOIR #1 & #2 & PUMP STATION
1200 WELLESLEY DR. SE
PLANTING PLAN

LANDSCAPING IMPROVEMENTS FOR
WATER SYSTEM FACILITY SITES
WATER SYSTEMS DIVISION
CITY OF ALBUQUERQUE
ALBUQUERQUE, NEW MEXICO

SHEET
13
OF
172

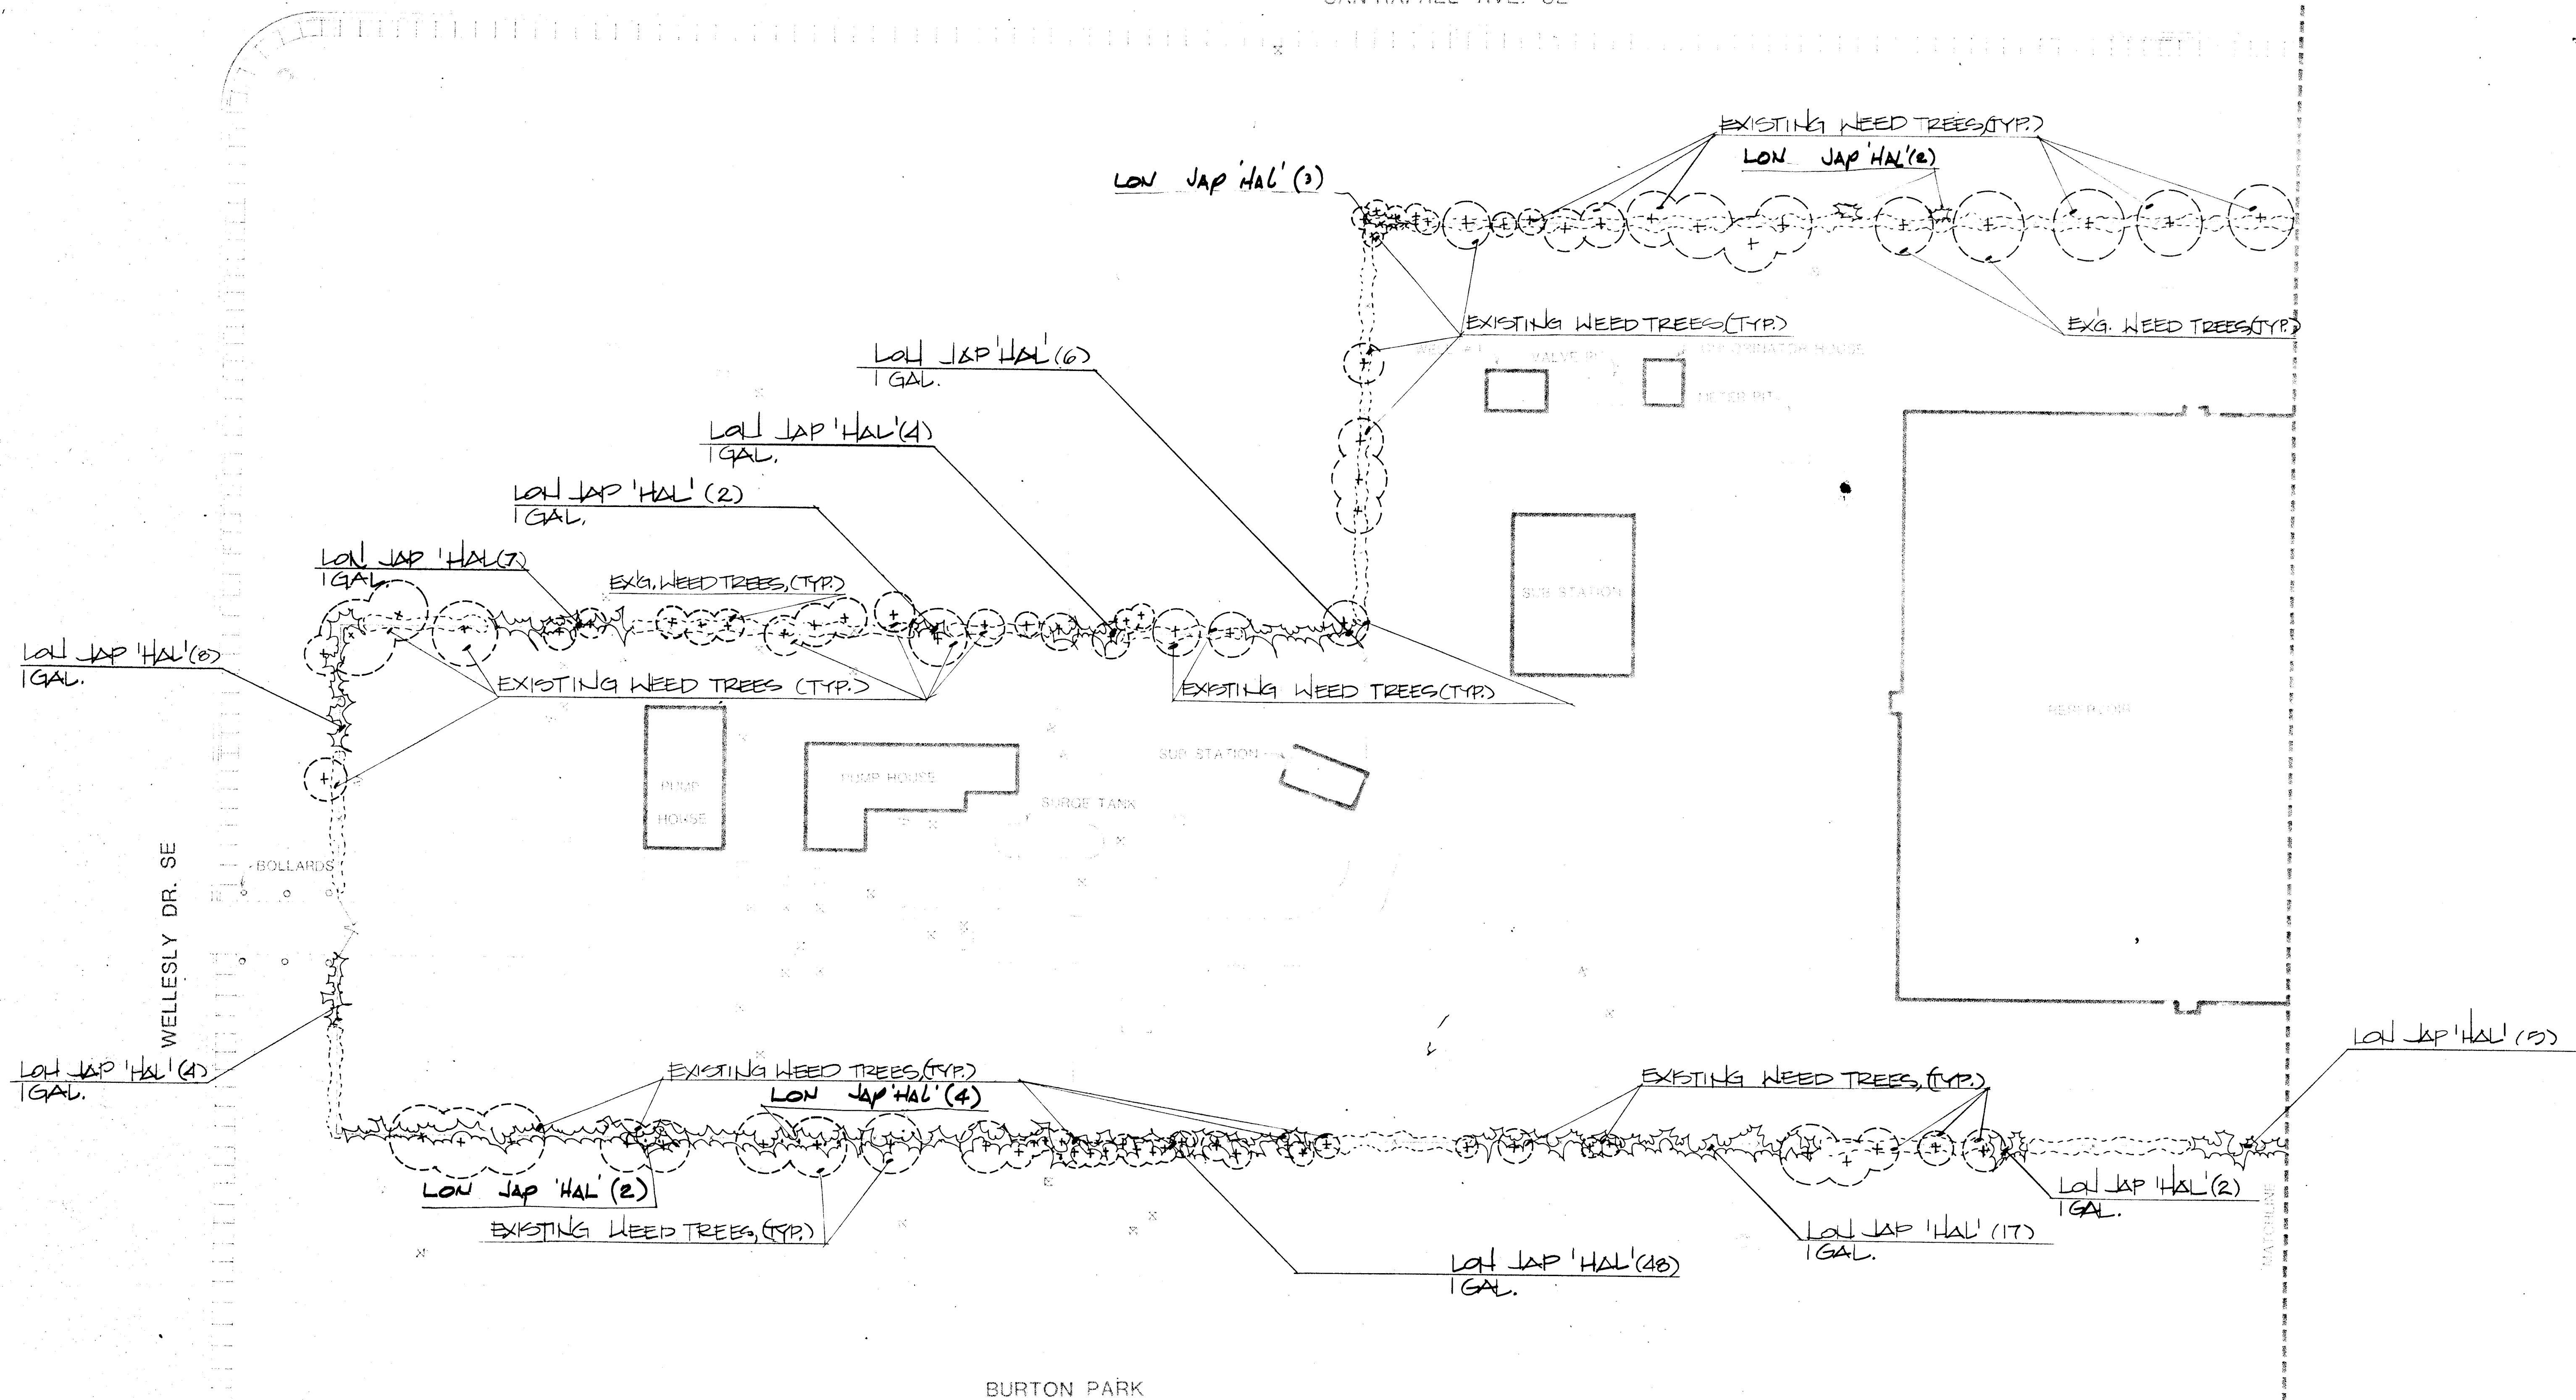


NOTES:

1. PLANT HONEYSUCKLE ± 12" FROM FENCE (ALONG OUTER SIDE OF FENCE).
2. EXISTING 'WEED TREES' (APPROXIMATELY 125 EACH) TO BE REMOVED AT FENCE ARE SHOWN SCHEMATICALLY. CONTRACTOR SHALL VERIFY EXACT LOCATION IN FIELD. SEE NOTE #4.
3. EXISTING POST-MATURE VINES ARE LOCATED IN ALL AREAS TO RECEIVE NEW VINES. EXISTING VINES IN THESE AREAS SHALL BE REMOVED AND PROPERLY DISPOSED OF.
4. EXISTING WEED TREES TO BE REMOVED AT FENCE ARE LOCATED ON BOTH SIDES OF THE FENCE. WEED TREES WITHIN 10'-0" OF EITHER SIDE OF FENCE SHALL BE REMOVED.

SCALE 1"=20'-0"

0 10 20 40

26 3097 1486

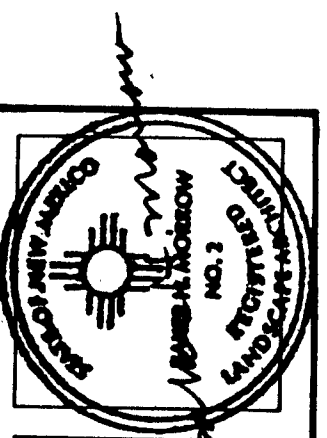

MORROW & COMPANY
LANDSCAPE ARCHITECTS
210 La Veta Drive NE
Albuquerque, New Mexico 87108
505-268-2266


NOVEMBER
1986

BURTON RESERVOIR #1, #2 AND PUMP STATION
1200 WELLESLEY DR. SE
PLANTING PLAN

AS BUILT

LANDSCAPING IMPROVEMENTS FOR
WATER SYSTEM FACILITY SITES
WATER SYSTEMS DIVISION
CITY OF ALBUQUERQUE
ALBUQUERQUE, NEW MEXICO

SHEET
14
172

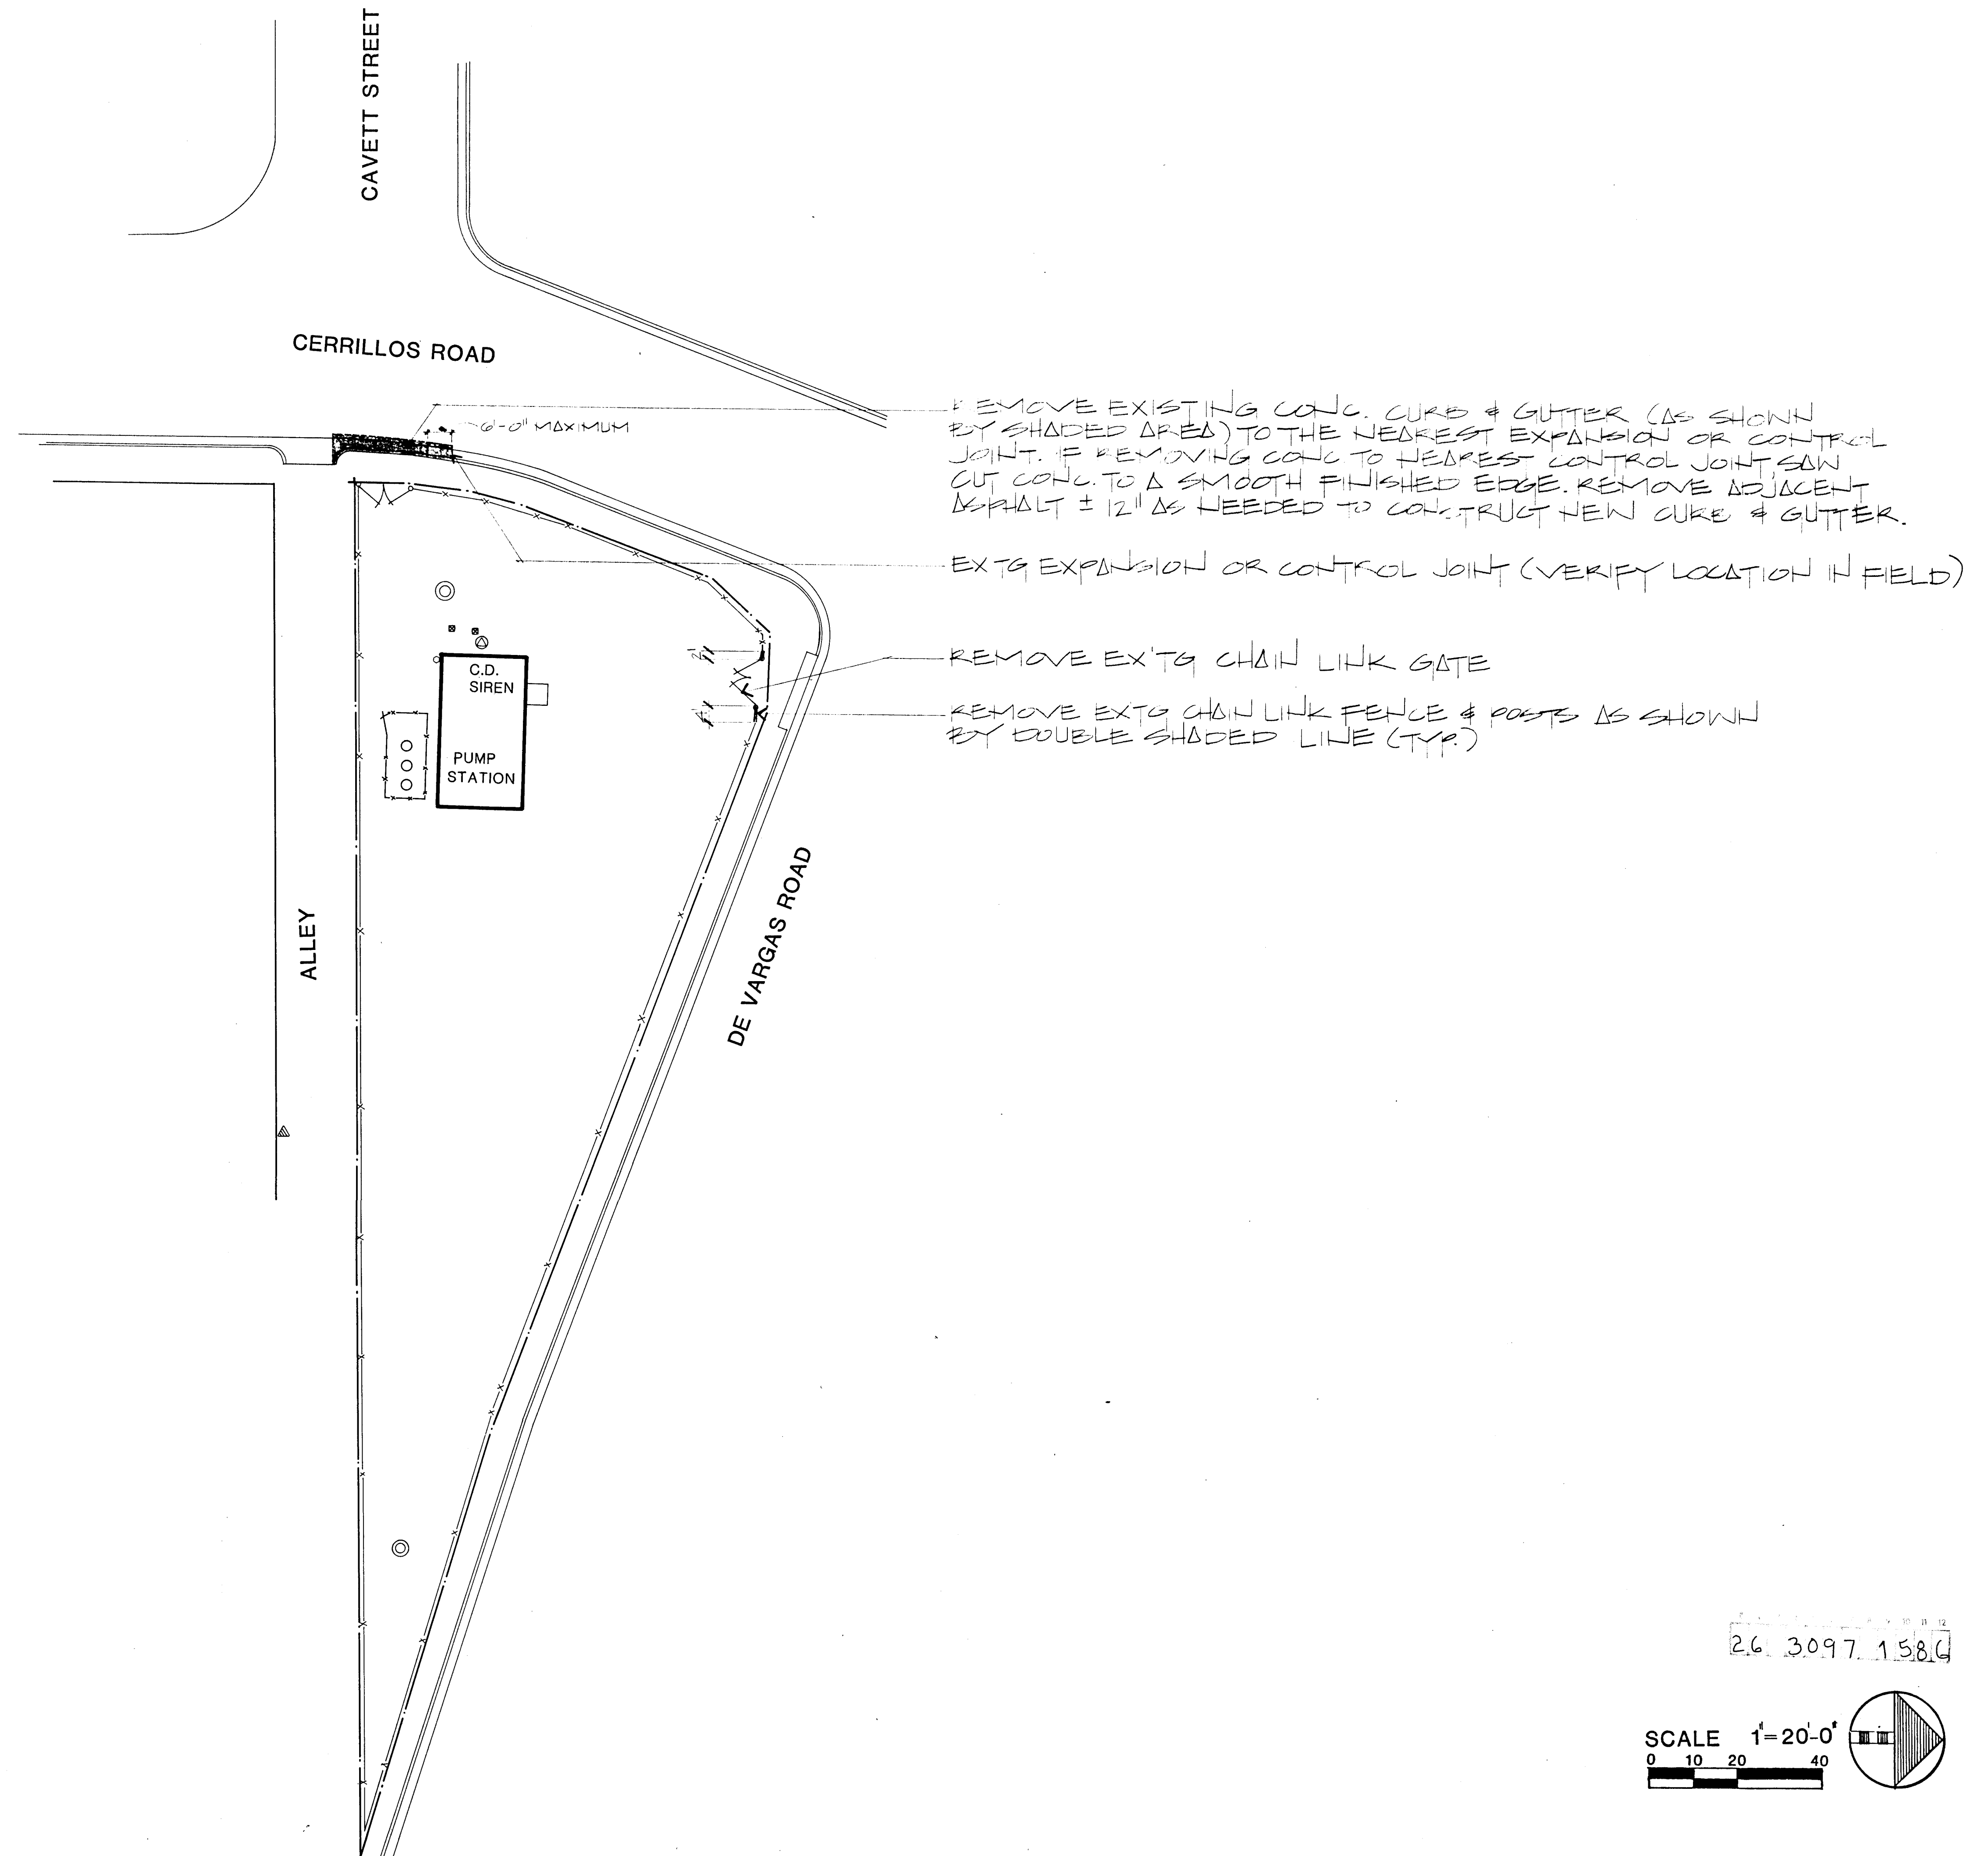

MORROW & COMPANY
LANDSCAPE ARCHITECTS
210 La Veta Drive NE
Albuquerque, New Mexico 87108
505-268-2266




NOVEMBER
1986

AS BUILT


DON PUMP STATION
1002 CERRILLOS ROAD SW
DEMOLITION PLAN

LANDSCAPING IMPROVEMENTS FOR
WATER SYSTEM FACILITY SITES
WATER SYSTEMS DIVISION
CITY OF ALBUQUERQUE
ALBUQUERQUE, NEW MEXICO

SHEET
172

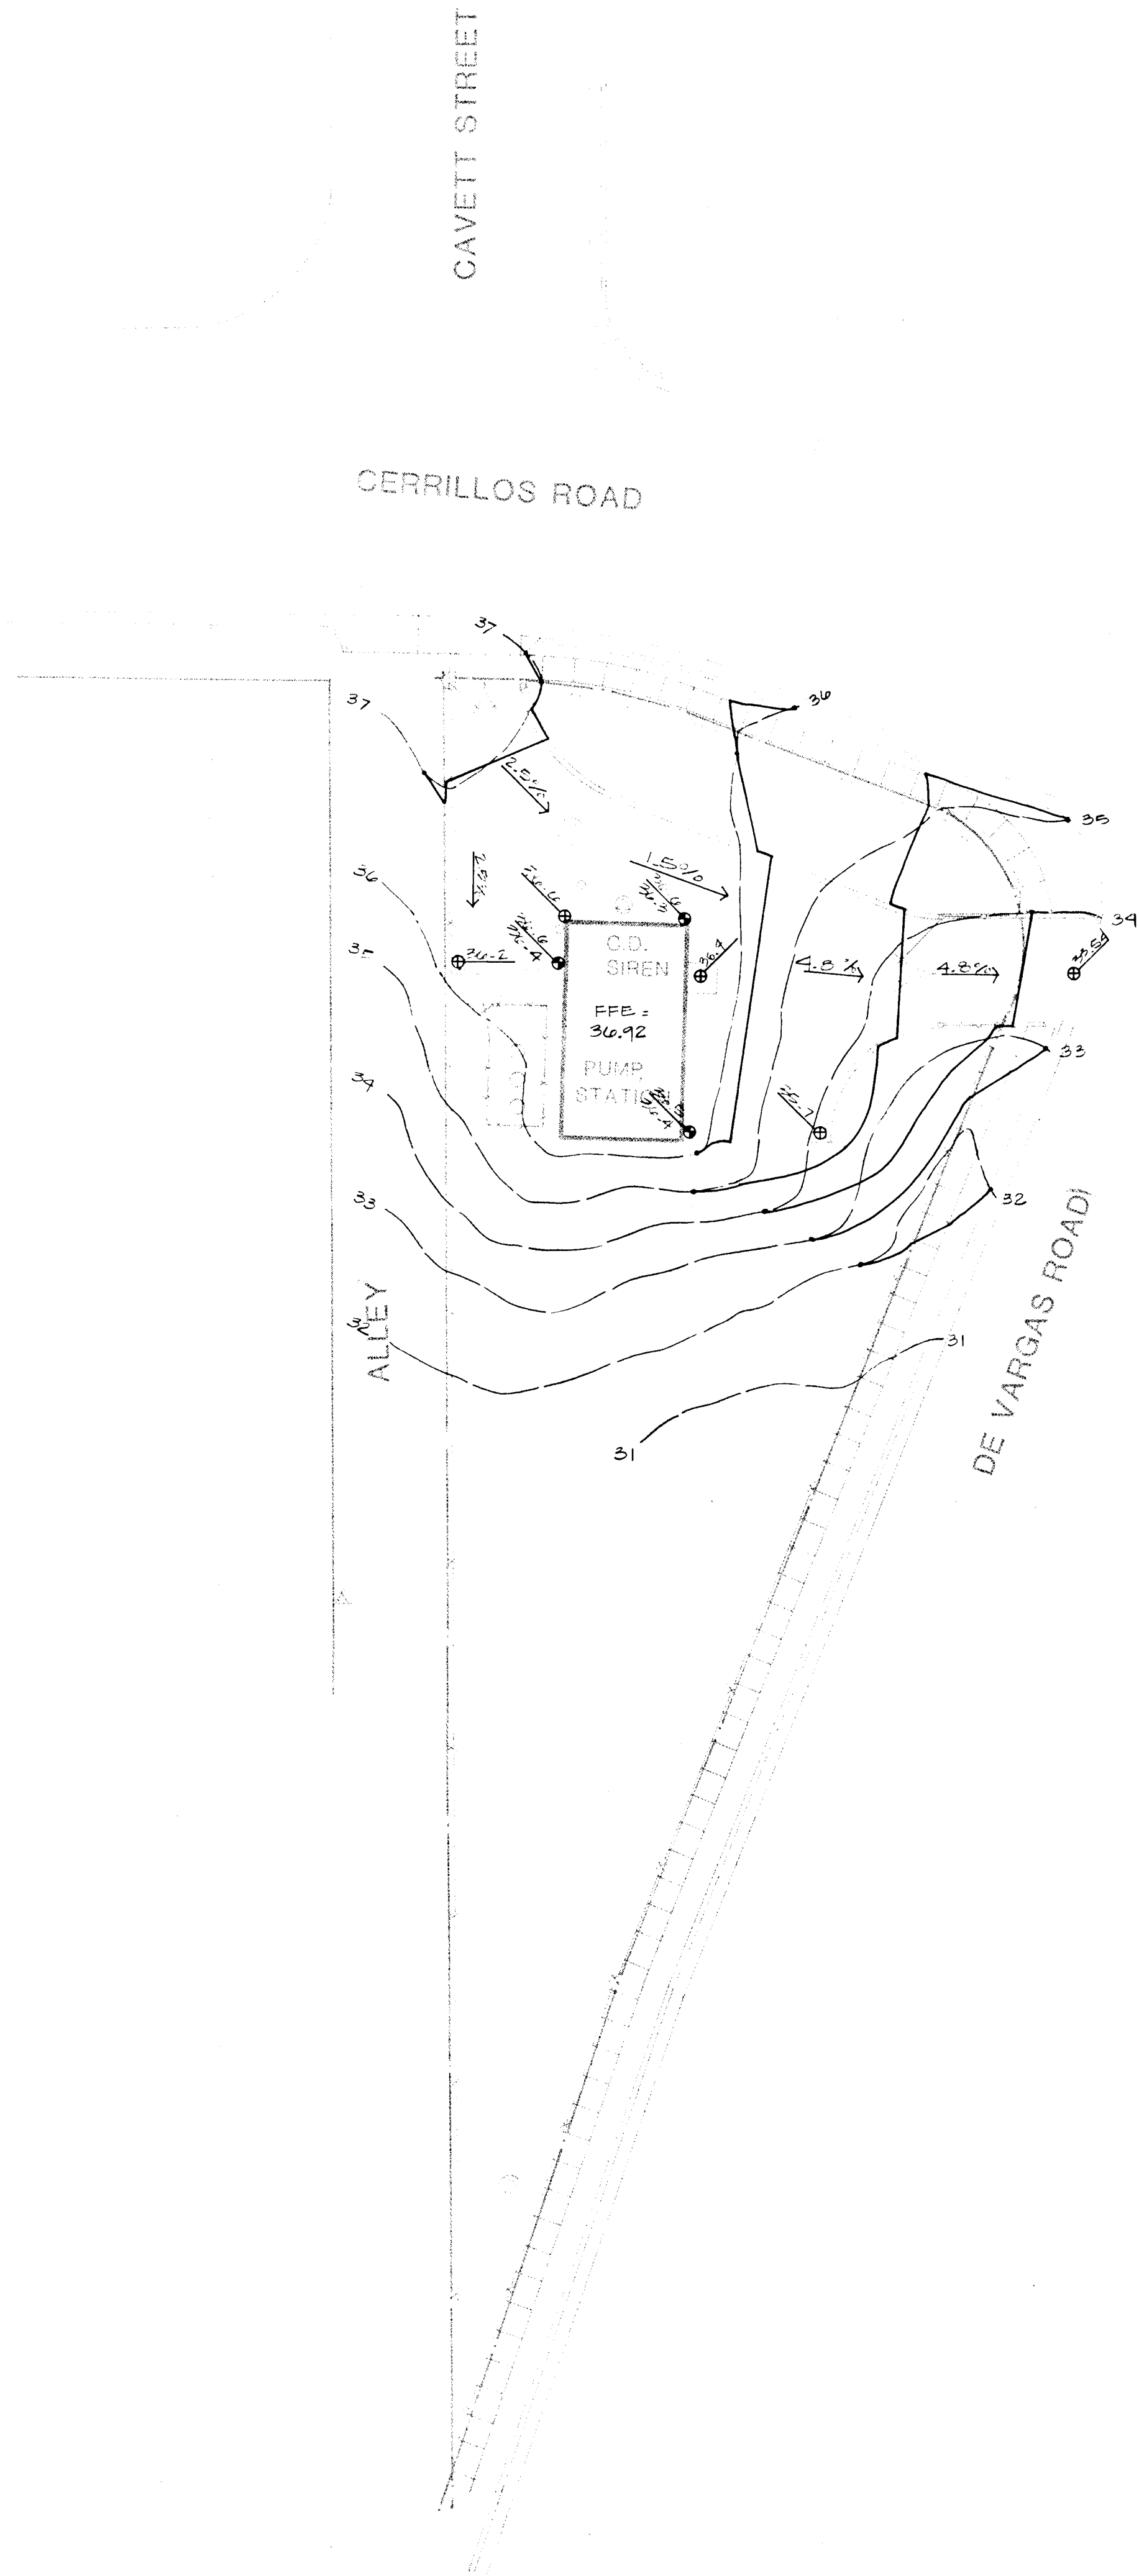

SCALE 1"=20'-0"

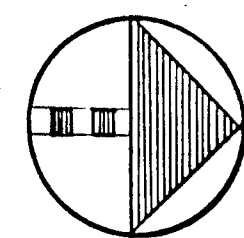

26 3097 1686


SHEET
16
OF
172

LANDSCAPING IMPROVEMENTS FOR
WATER SYSTEM FACILITY SITES
WATER SYSTEMS DIVISION
CITY OF ALBUQUERQUE
ALBUQUERQUE, NEW MEXICO


DON PUMP STATION
1002 CERRILLOS ROAD SW
GRADING PLAN


AS BUILT

NOVEMBER
1986

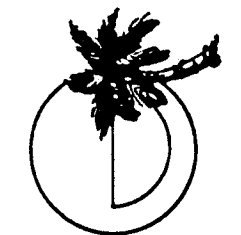


MORROW & COMPANY
LANDSCAPE ARCHITECTS
210 La Veta Drive NE
Albuquerque, New Mexico 87108
505-268-2266

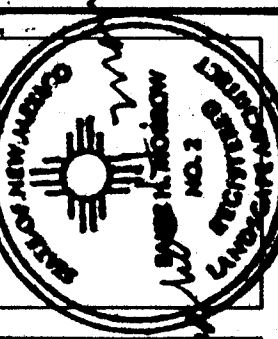


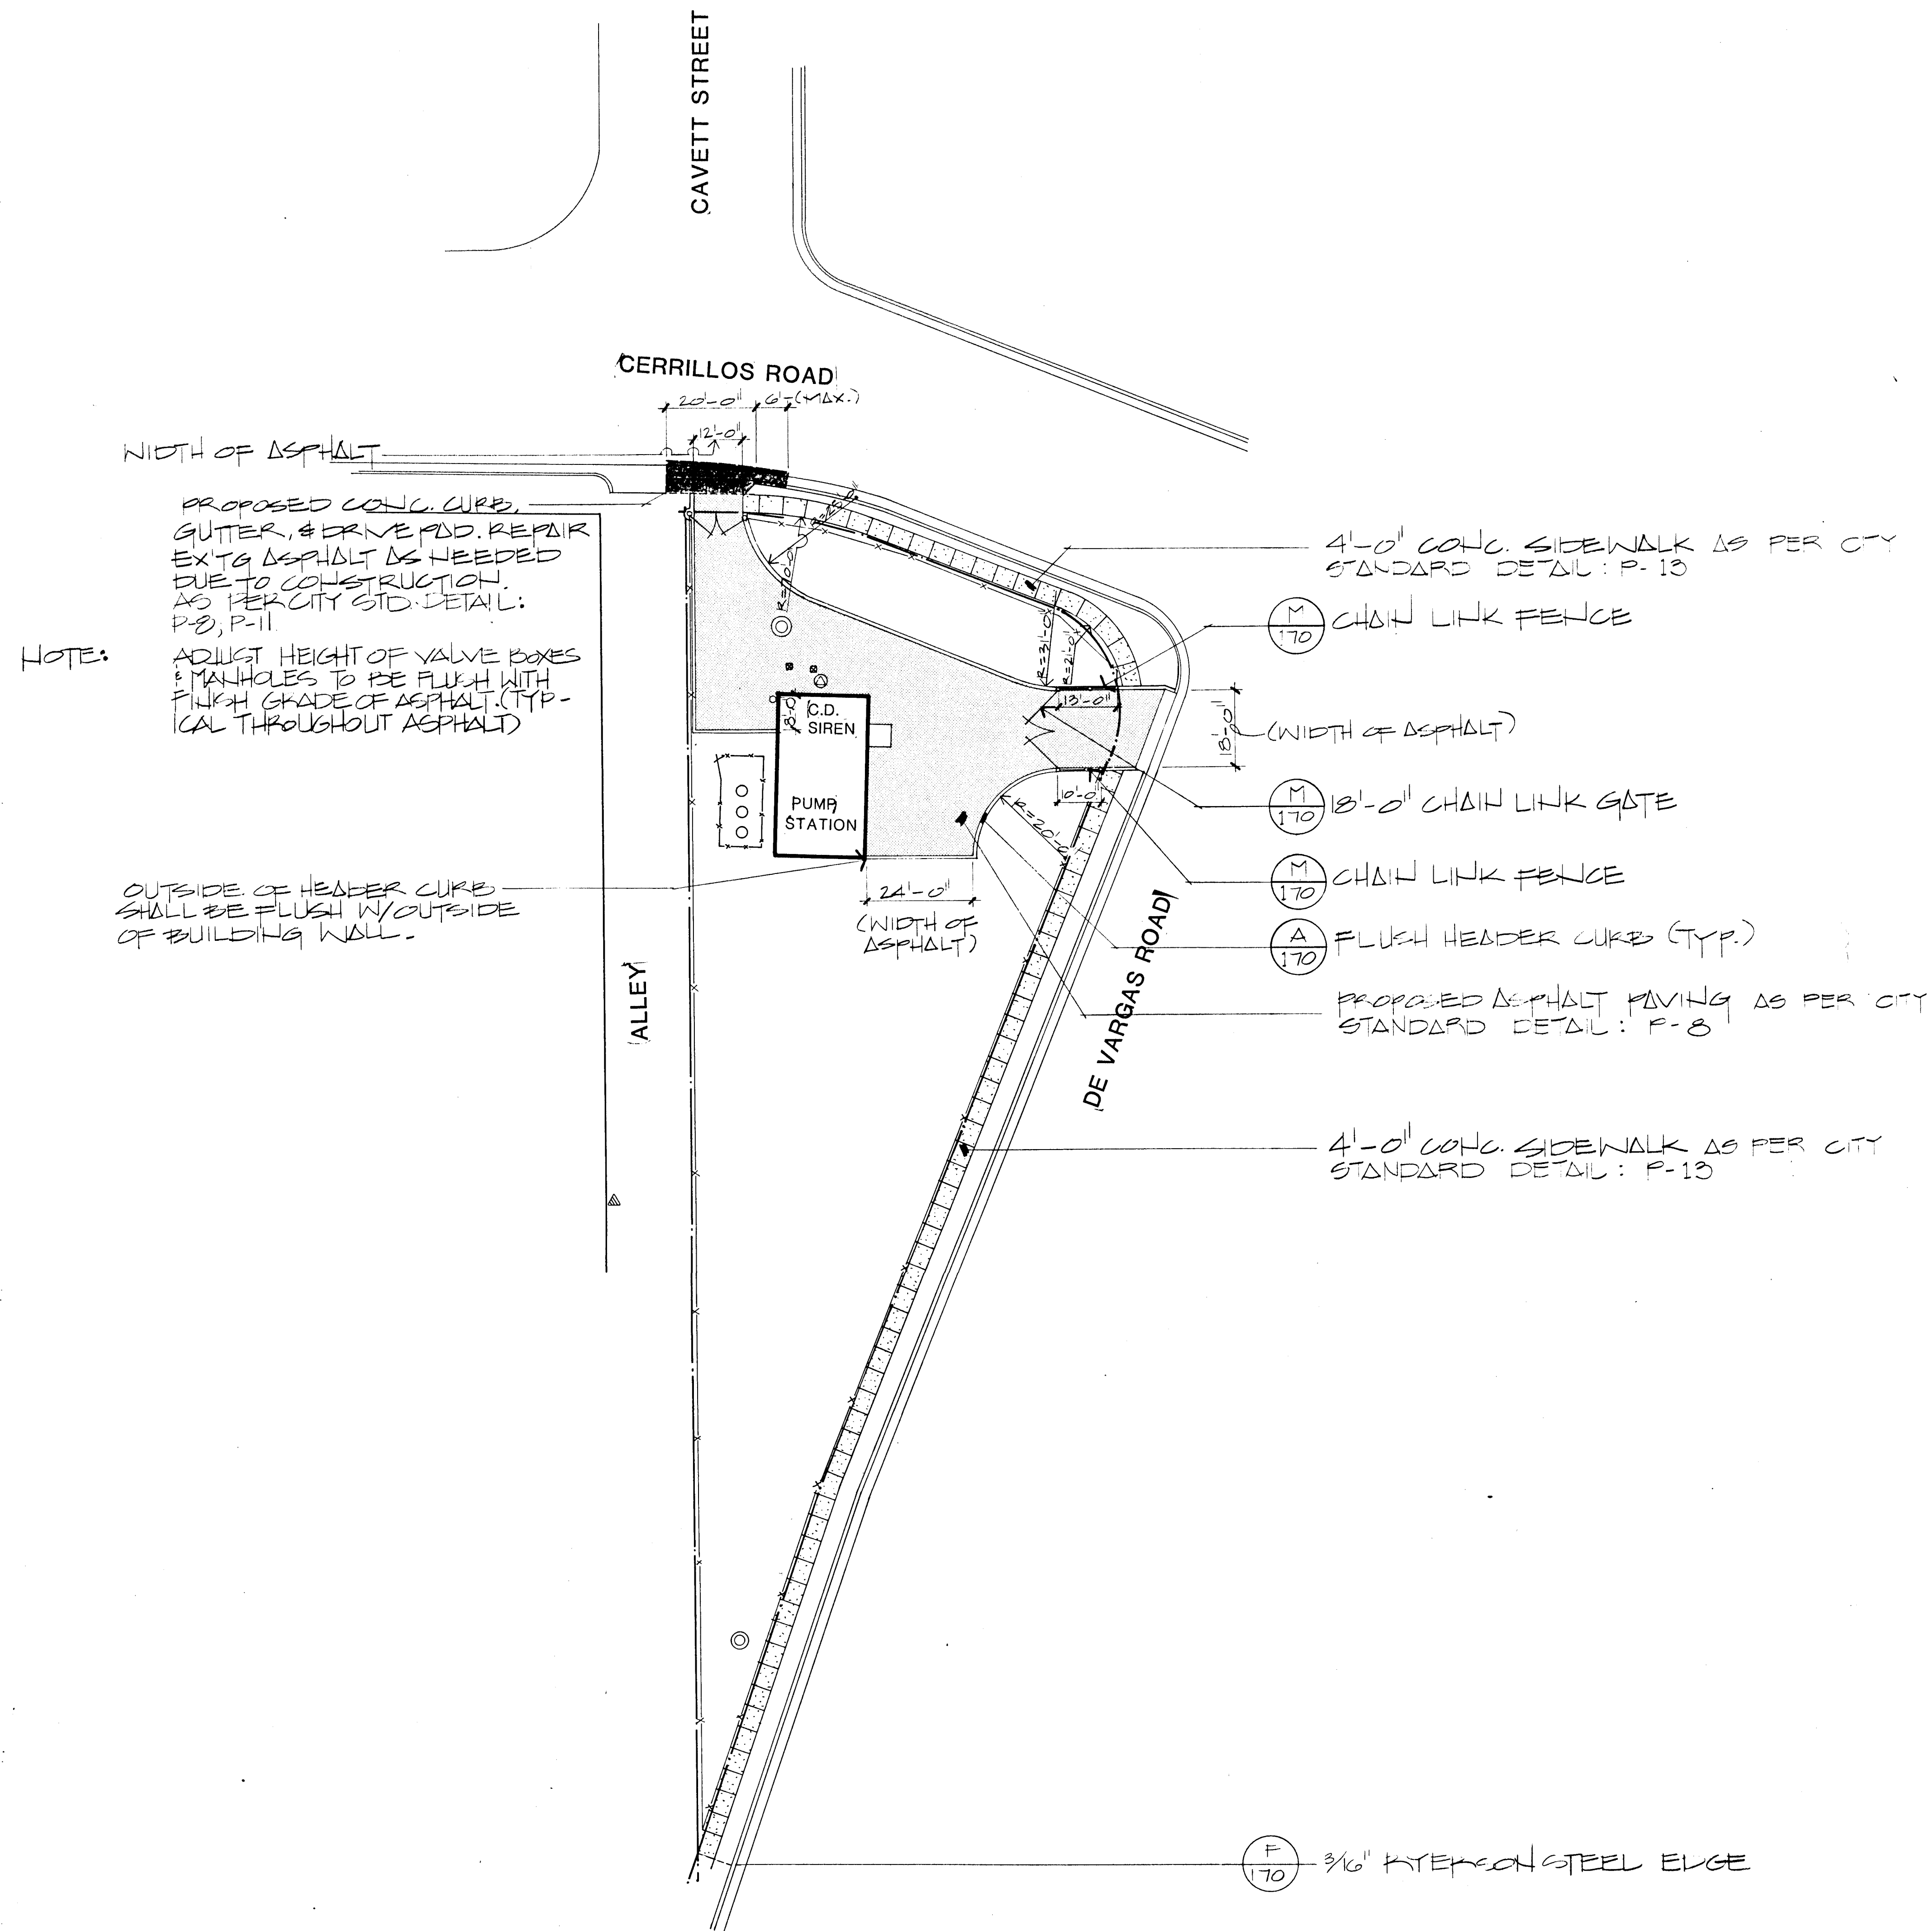

26 30.97 178.6

SCALE 1"=20'-0"

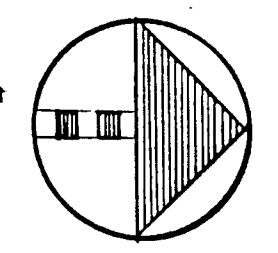

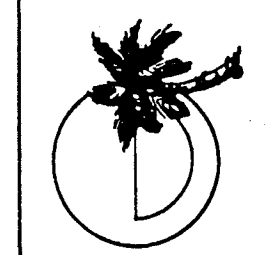

MORROW & COMPANY
LANDSCAPE ARCHITECTS
210 La Veta Drive NE
Albuquerque, New Mexico 87108
505-268-2266


NOVEMBER
1986

AS BUILT

LANDSCAPING IMPROVEMENTS FOR
WATER SYSTEM FACILITY SITES
WATER SYSTEMS DIVISION
CITY OF ALBUQUERQUE
ALBUQUERQUE, NEW MEXICO

DON PUMP STATION
1002 CERRILLOS ROAD SW
CONSTRUCTION PLAN

SHEET
17
OF
172

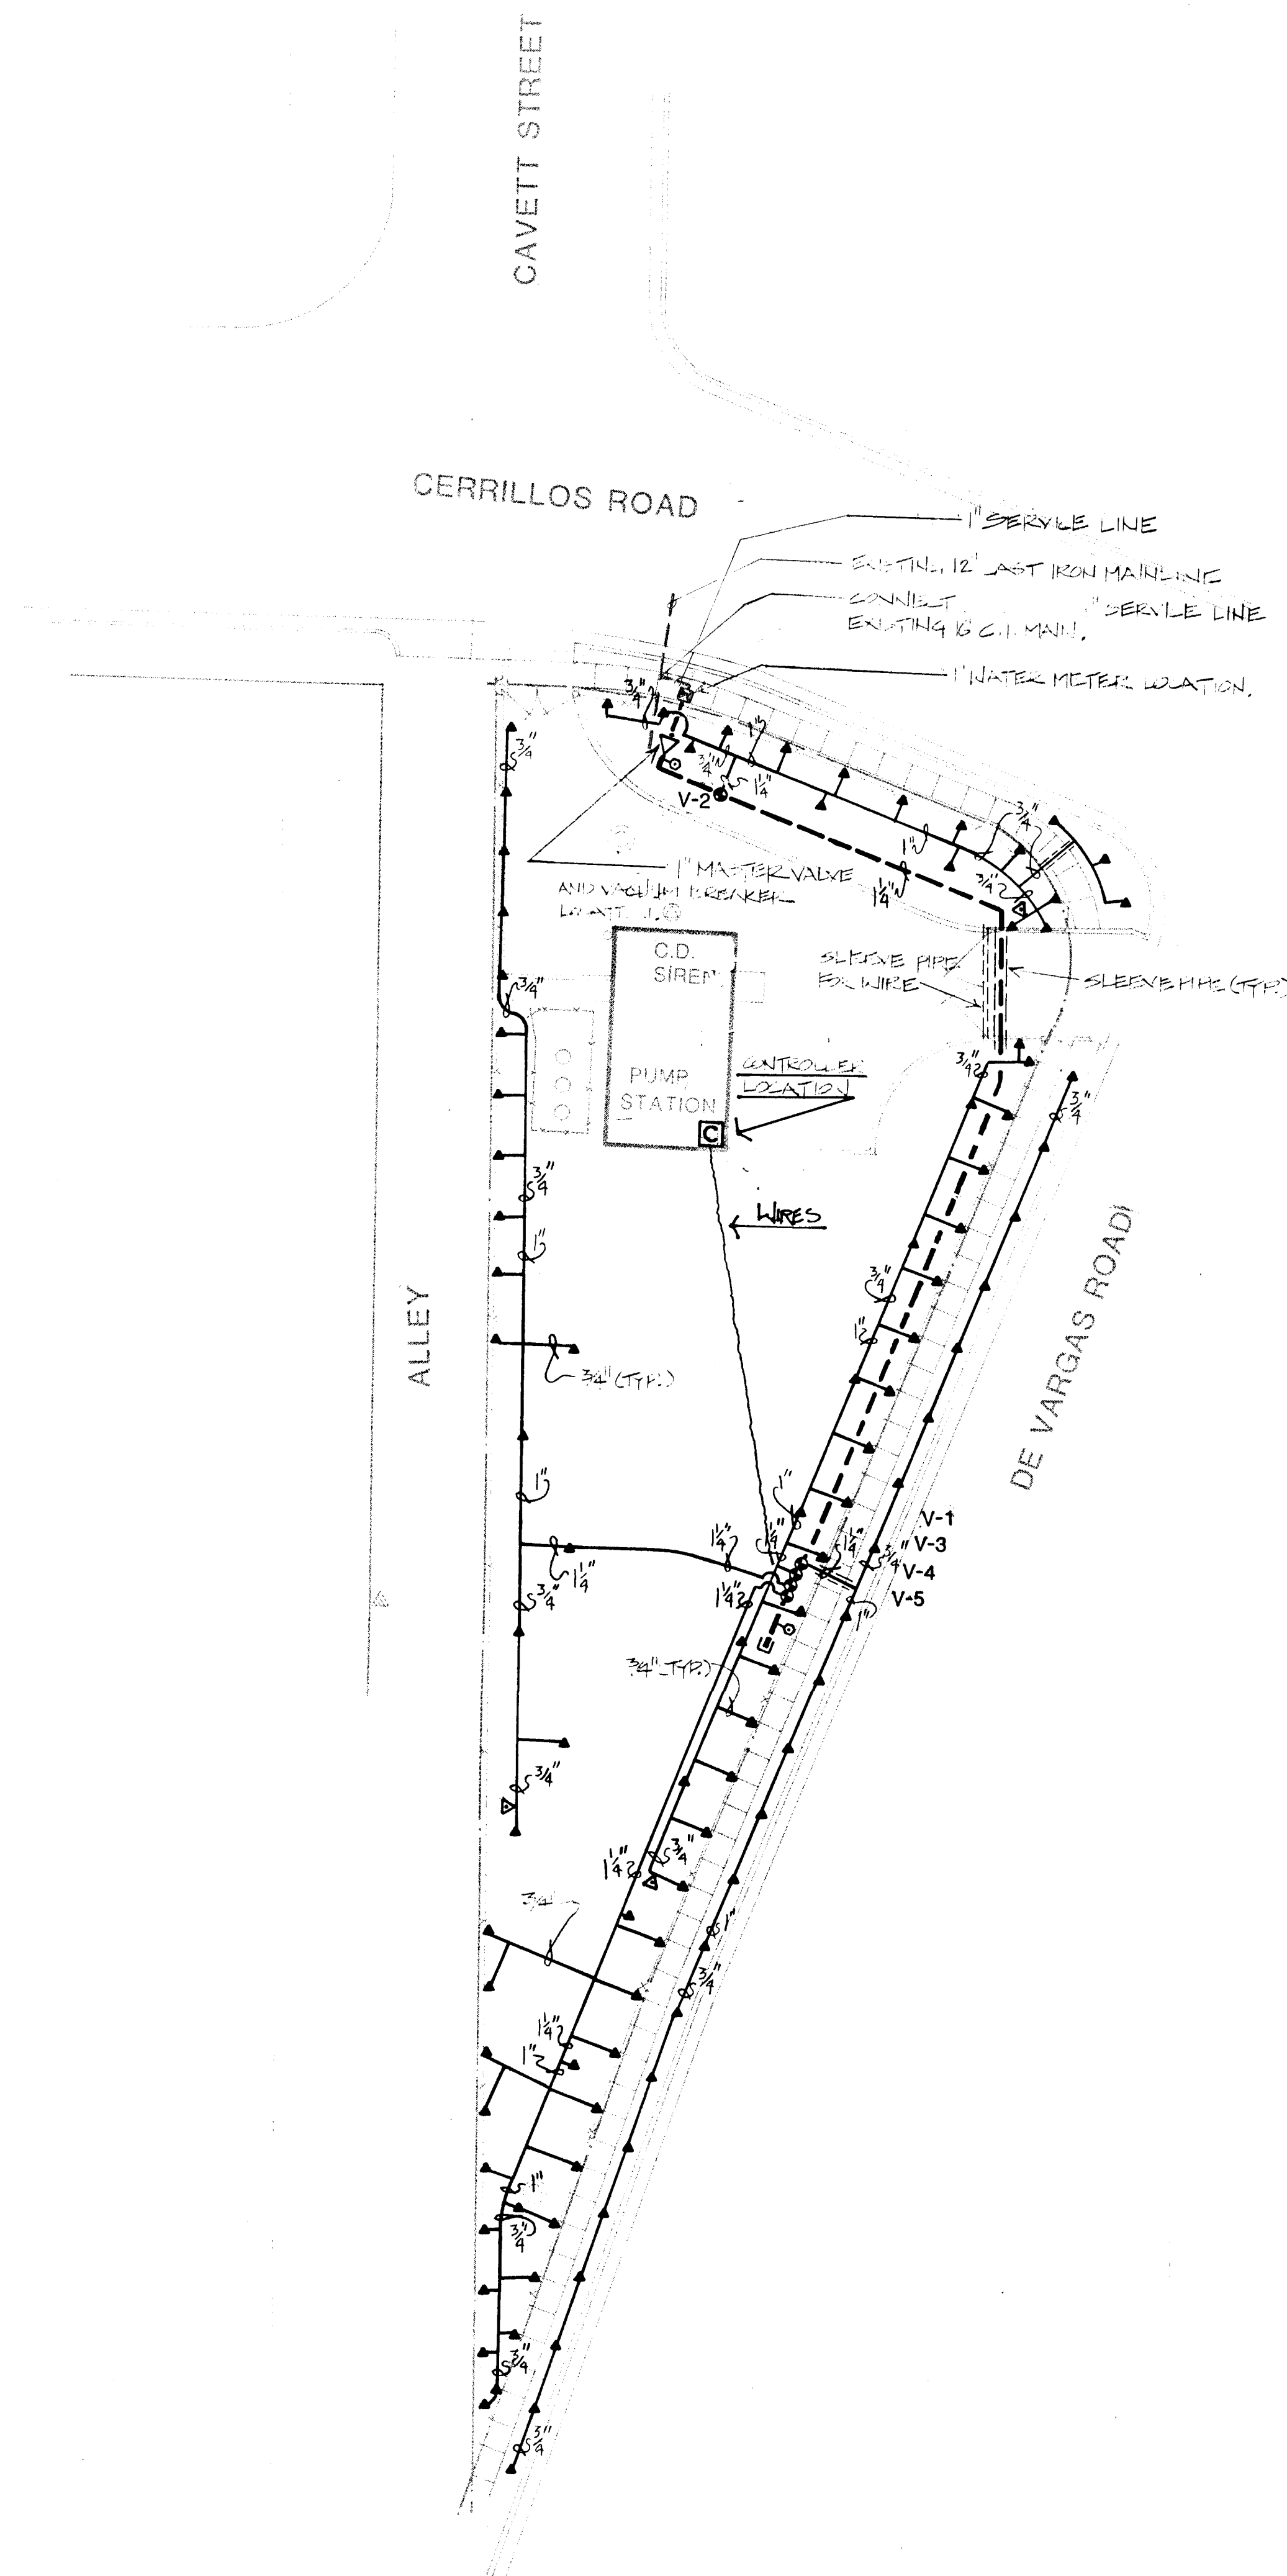



IRIGATION CONTROLLER
 ELECTRICAL PANEL →
 CIRCUIT # 8

3/4" RIGID STEEL CONDUIT, 110 VOLT CIRCUIT
 1/2" RIGID STEEL CONDUIT, 24 VOLT CIRCUITS
 TO REMOTE CONTROL VALVES


SCHEMATIC AS BUILT FOR 110 VOLT ELECTRICAL
 FROM SOURCE TO IRRIGATION CONTROLLER

26 3097 1886

SCALE 1"=20'-0"
 0 10 20 40

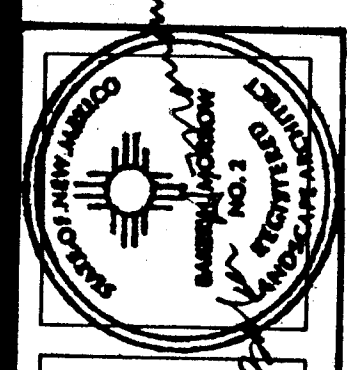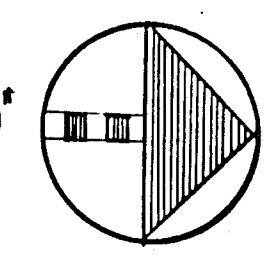

MORROW & COMPANY
 LANDSCAPE ARCHITECTS
 210 La Veta Drive NE
 Albuquerque, New Mexico 87108
 505-268-2266

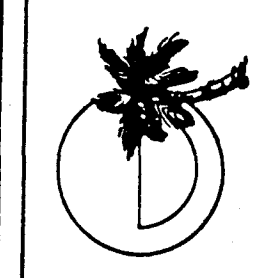


NOVEMBER
 1986

AS BUILT

DON PUMP STATION
 1002 CERRILLOS ROAD SW
 IRRIGATION PLAN


LANDSCAPING IMPROVEMENTS FOR
WATER SYSTEM FACILITY SITES
 WATER SYSTEMS DIVISION
 CITY OF ALBUQUERQUE
 ALBUQUERQUE, NEW MEXICO

SHEET
 18
 172

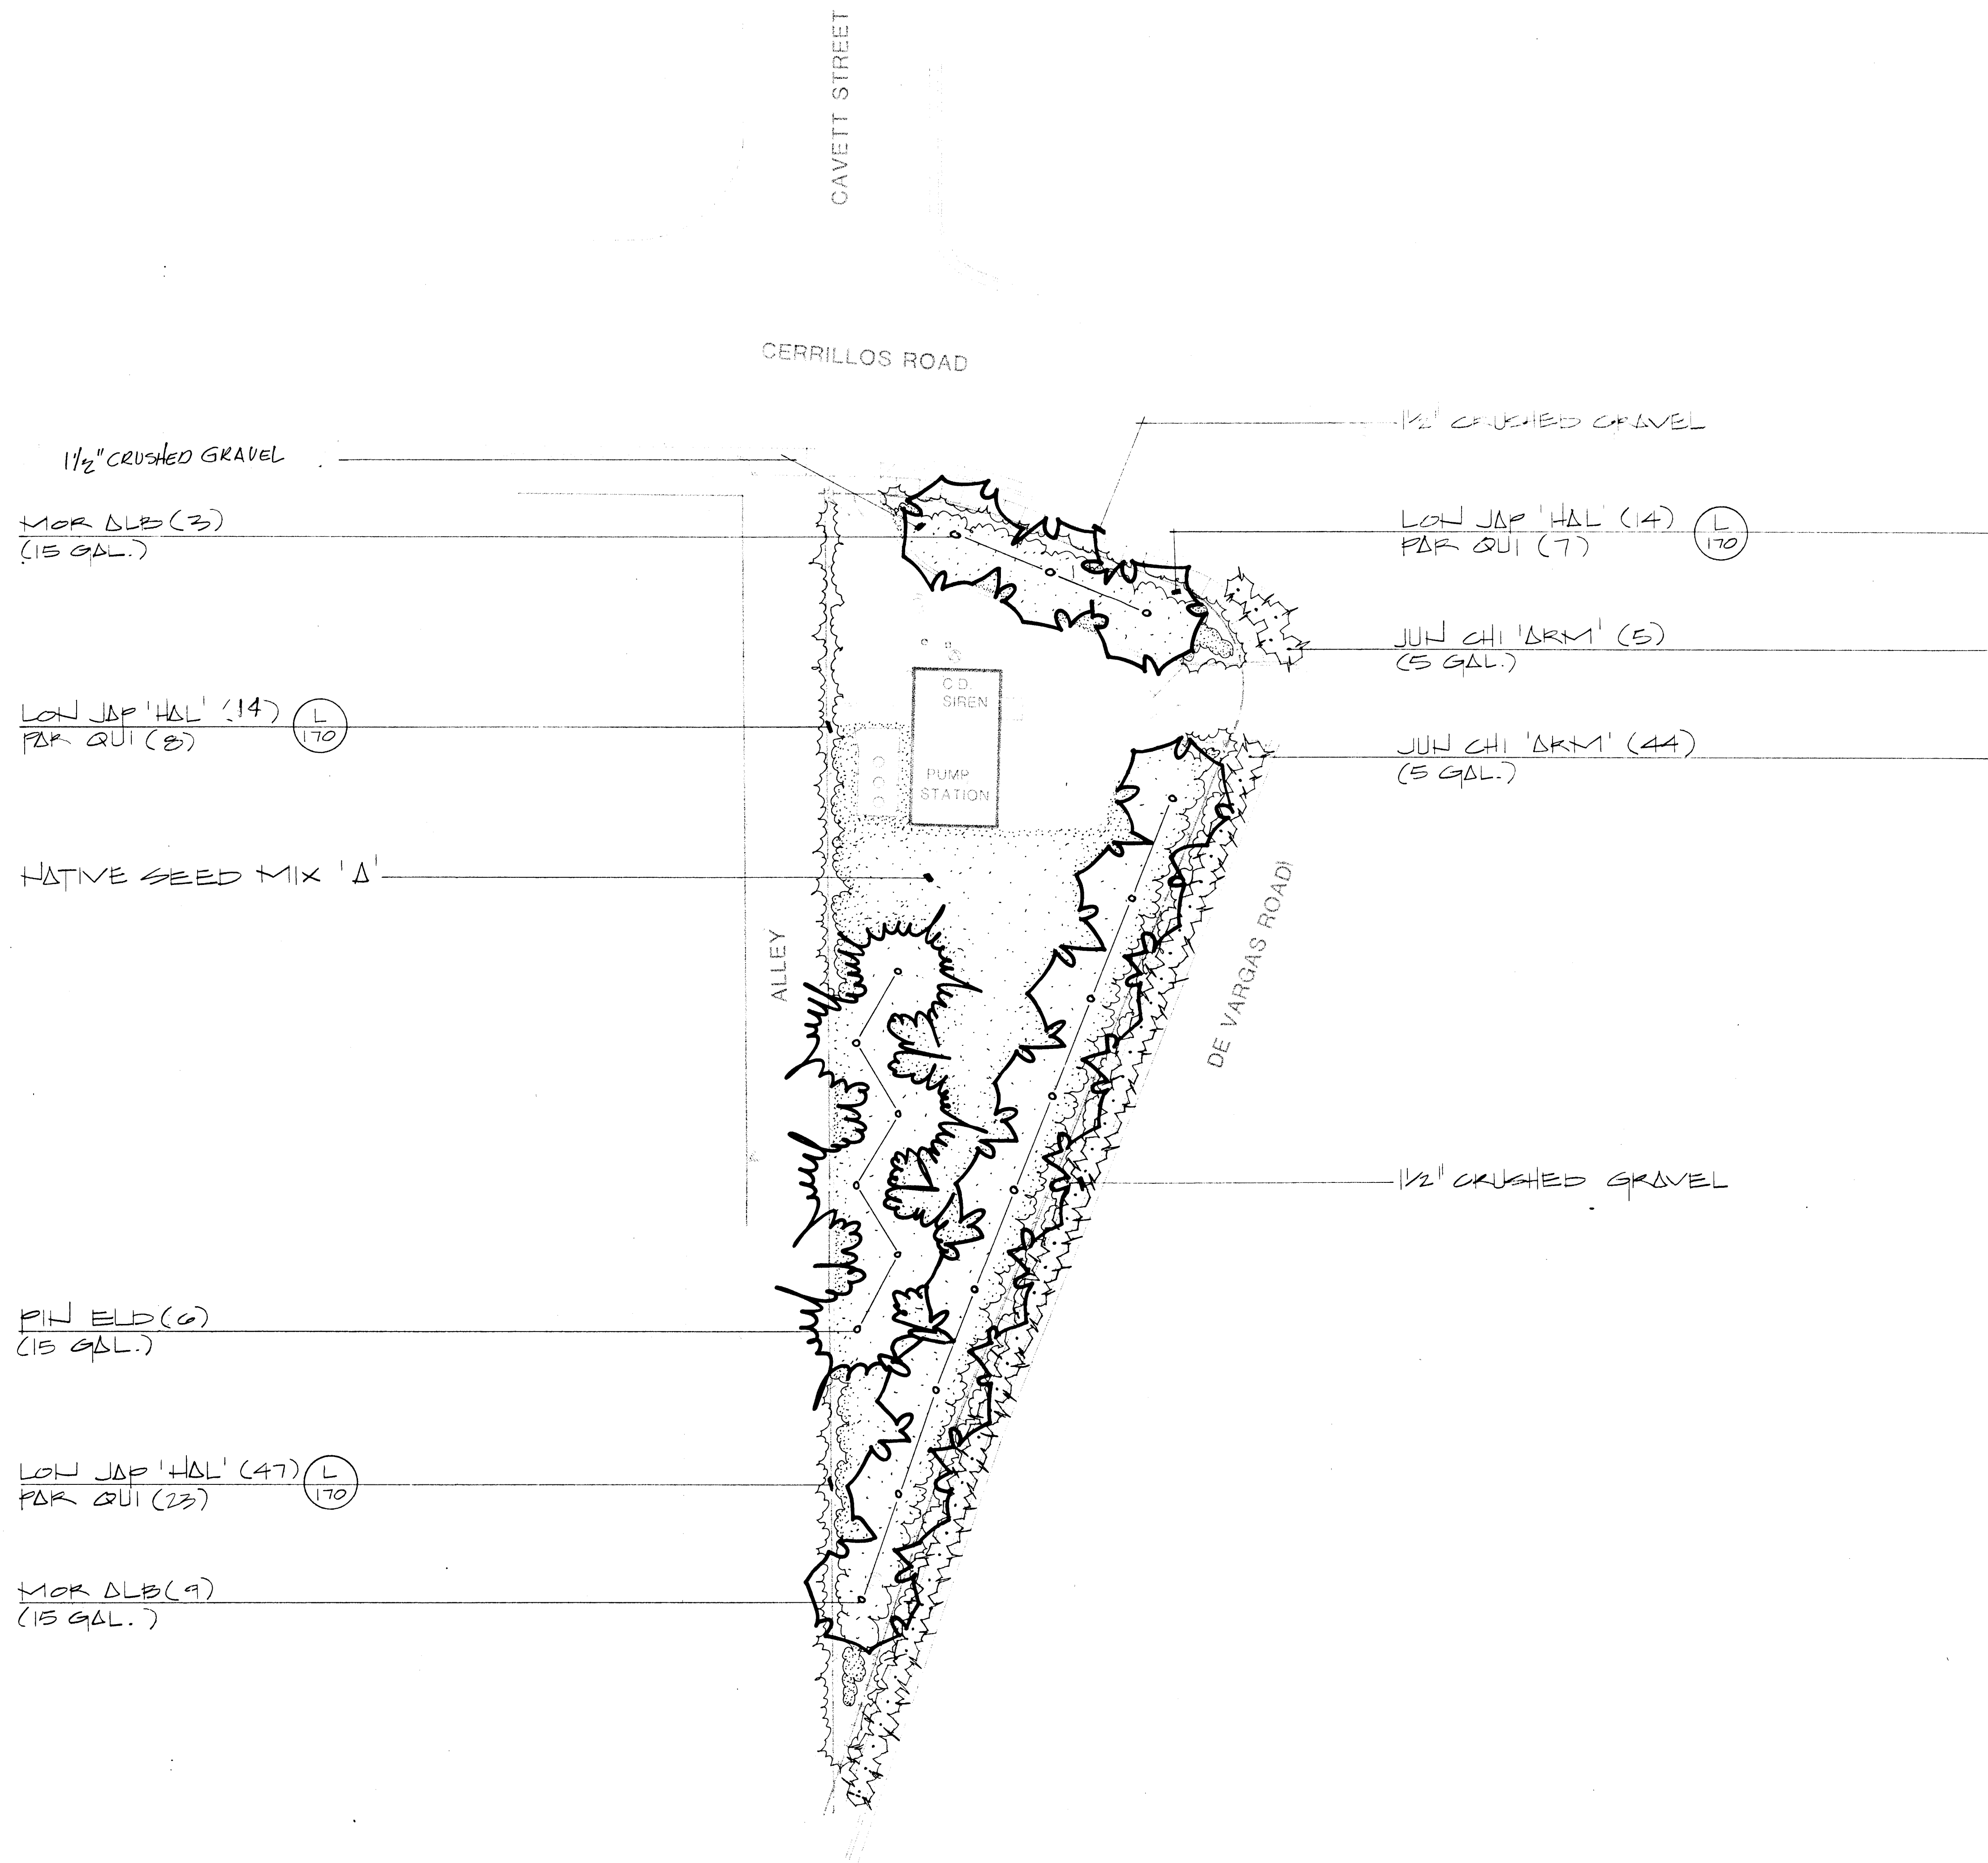

26 3097 1986

SCALE 1"=20'-0"

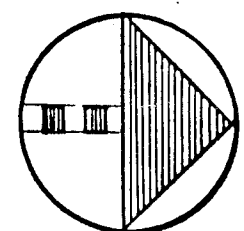

MORROW & COMPANY
LANDSCAPE ARCHITECTS
210 La Veta Drive NE
Albuquerque, New Mexico 87108
505-268-2266

NOVEMBER
1986

AS BUILT

DON PUMP STATION
1002 CERRILLOS ROAD SW
PLANTING PLAN

LANDSCAPING IMPROVEMENTS FOR
WATER SYSTEM FACILITY SITES
WATER SYSTEMS DIVISION
CITY OF ALBUQUERQUE
ALBUQUERQUE, NEW MEXICO

SHEET
19
OF
172

APPLE LANE NW

DITCH

RESERVOIR

EXISTING TRANSFORMERS
& DEBRIS TO BE REMOVED
BY OWNER

VALVE PIT

CHLORINATOR
HOUSE

VALVE PIT

PUMP STATION

CHERRY LANE NW

REMOVE EXISTING CHAIN LINK FENCE
BETWEEN EXISTING GATE POSTS

REMOVE EXISTING TREE

REMOVE EXISTING CHAIN LINK FENCE
AS SHOWN BY DOUBLE DASHED LINE

REMOVE EXISTING CONC. SLAB


REMOVE EXISTING CHAIN LINK FENCE
AS SHOWN BY DOUBLE DASHED LINE

ALLEY

NOTE:
New chlorine facilities and asphalt paving may be under construction (by others -
NIC) during the construction of the landscape improvements described herein. The
Contractor shall coordinate all proposed landscape demolition and construction
with the on-going construction of the chlorine facilities and asphalt paving. The
Contractor shall notify the Landscape Architect of any problems that may occur
concerning the coordination of the two projects.

NOTE:
CONTRACTOR MAY RELIEVE PORTIONS OF
EXISTING FENCE AS APPROPRIATE. EX-
ISTING FENCE THAT IS DAMAGED IN ANY
WAY SHALL NOT BE RELIEVED.

SCALE 1"=20'-0"
0 10 20 40

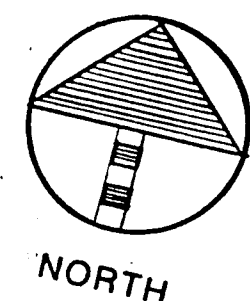

26 3097 2086


MORROW & COMPANY
LANDSCAPE ARCHITECTS
210 La Veta Drive NE
Albuquerque, New Mexico 87108
505-268-2266

NOVEMBER
1986

DURANES RESERVOIR & PUMP STATION
1917 CHERRY LANE NW
DEMOLITION PLAN
AS BUILT

LANDSCAPING IMPROVEMENTS FOR
WATER SYSTEM FACILITY SITES
WATER SYSTEMS DIVISION
CITY OF ALBUQUERQUE
ALBUQUERQUE, NEW MEXICO

SHEET
26
OF
172

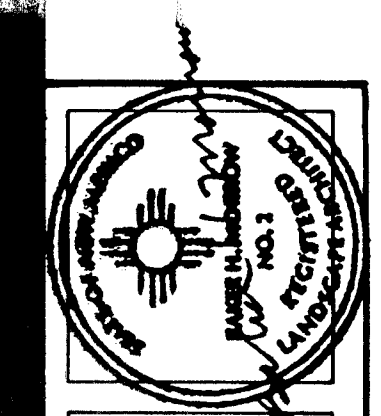


MORROW & COMPANY
LANDSCAPE ARCHITECTS
210 La Veta Drive NE
Albuquerque, New Mexico 87108
505-268-2266

NOVEMBER
1986

AS BUILT
DURANES RESERVOIR & PUMP STATION
1917 CHERRY LANE NW
CONSTRUCTION PLAN

LANDSCAPING IMPROVEMENTS FOR
WATER SYSTEM FACILITY SITES
WATER SYSTEMS DIVISION
CITY OF ALBUQUERQUE
ALBUQUERQUE, NEW MEXICO


SHEET
21
OF
172

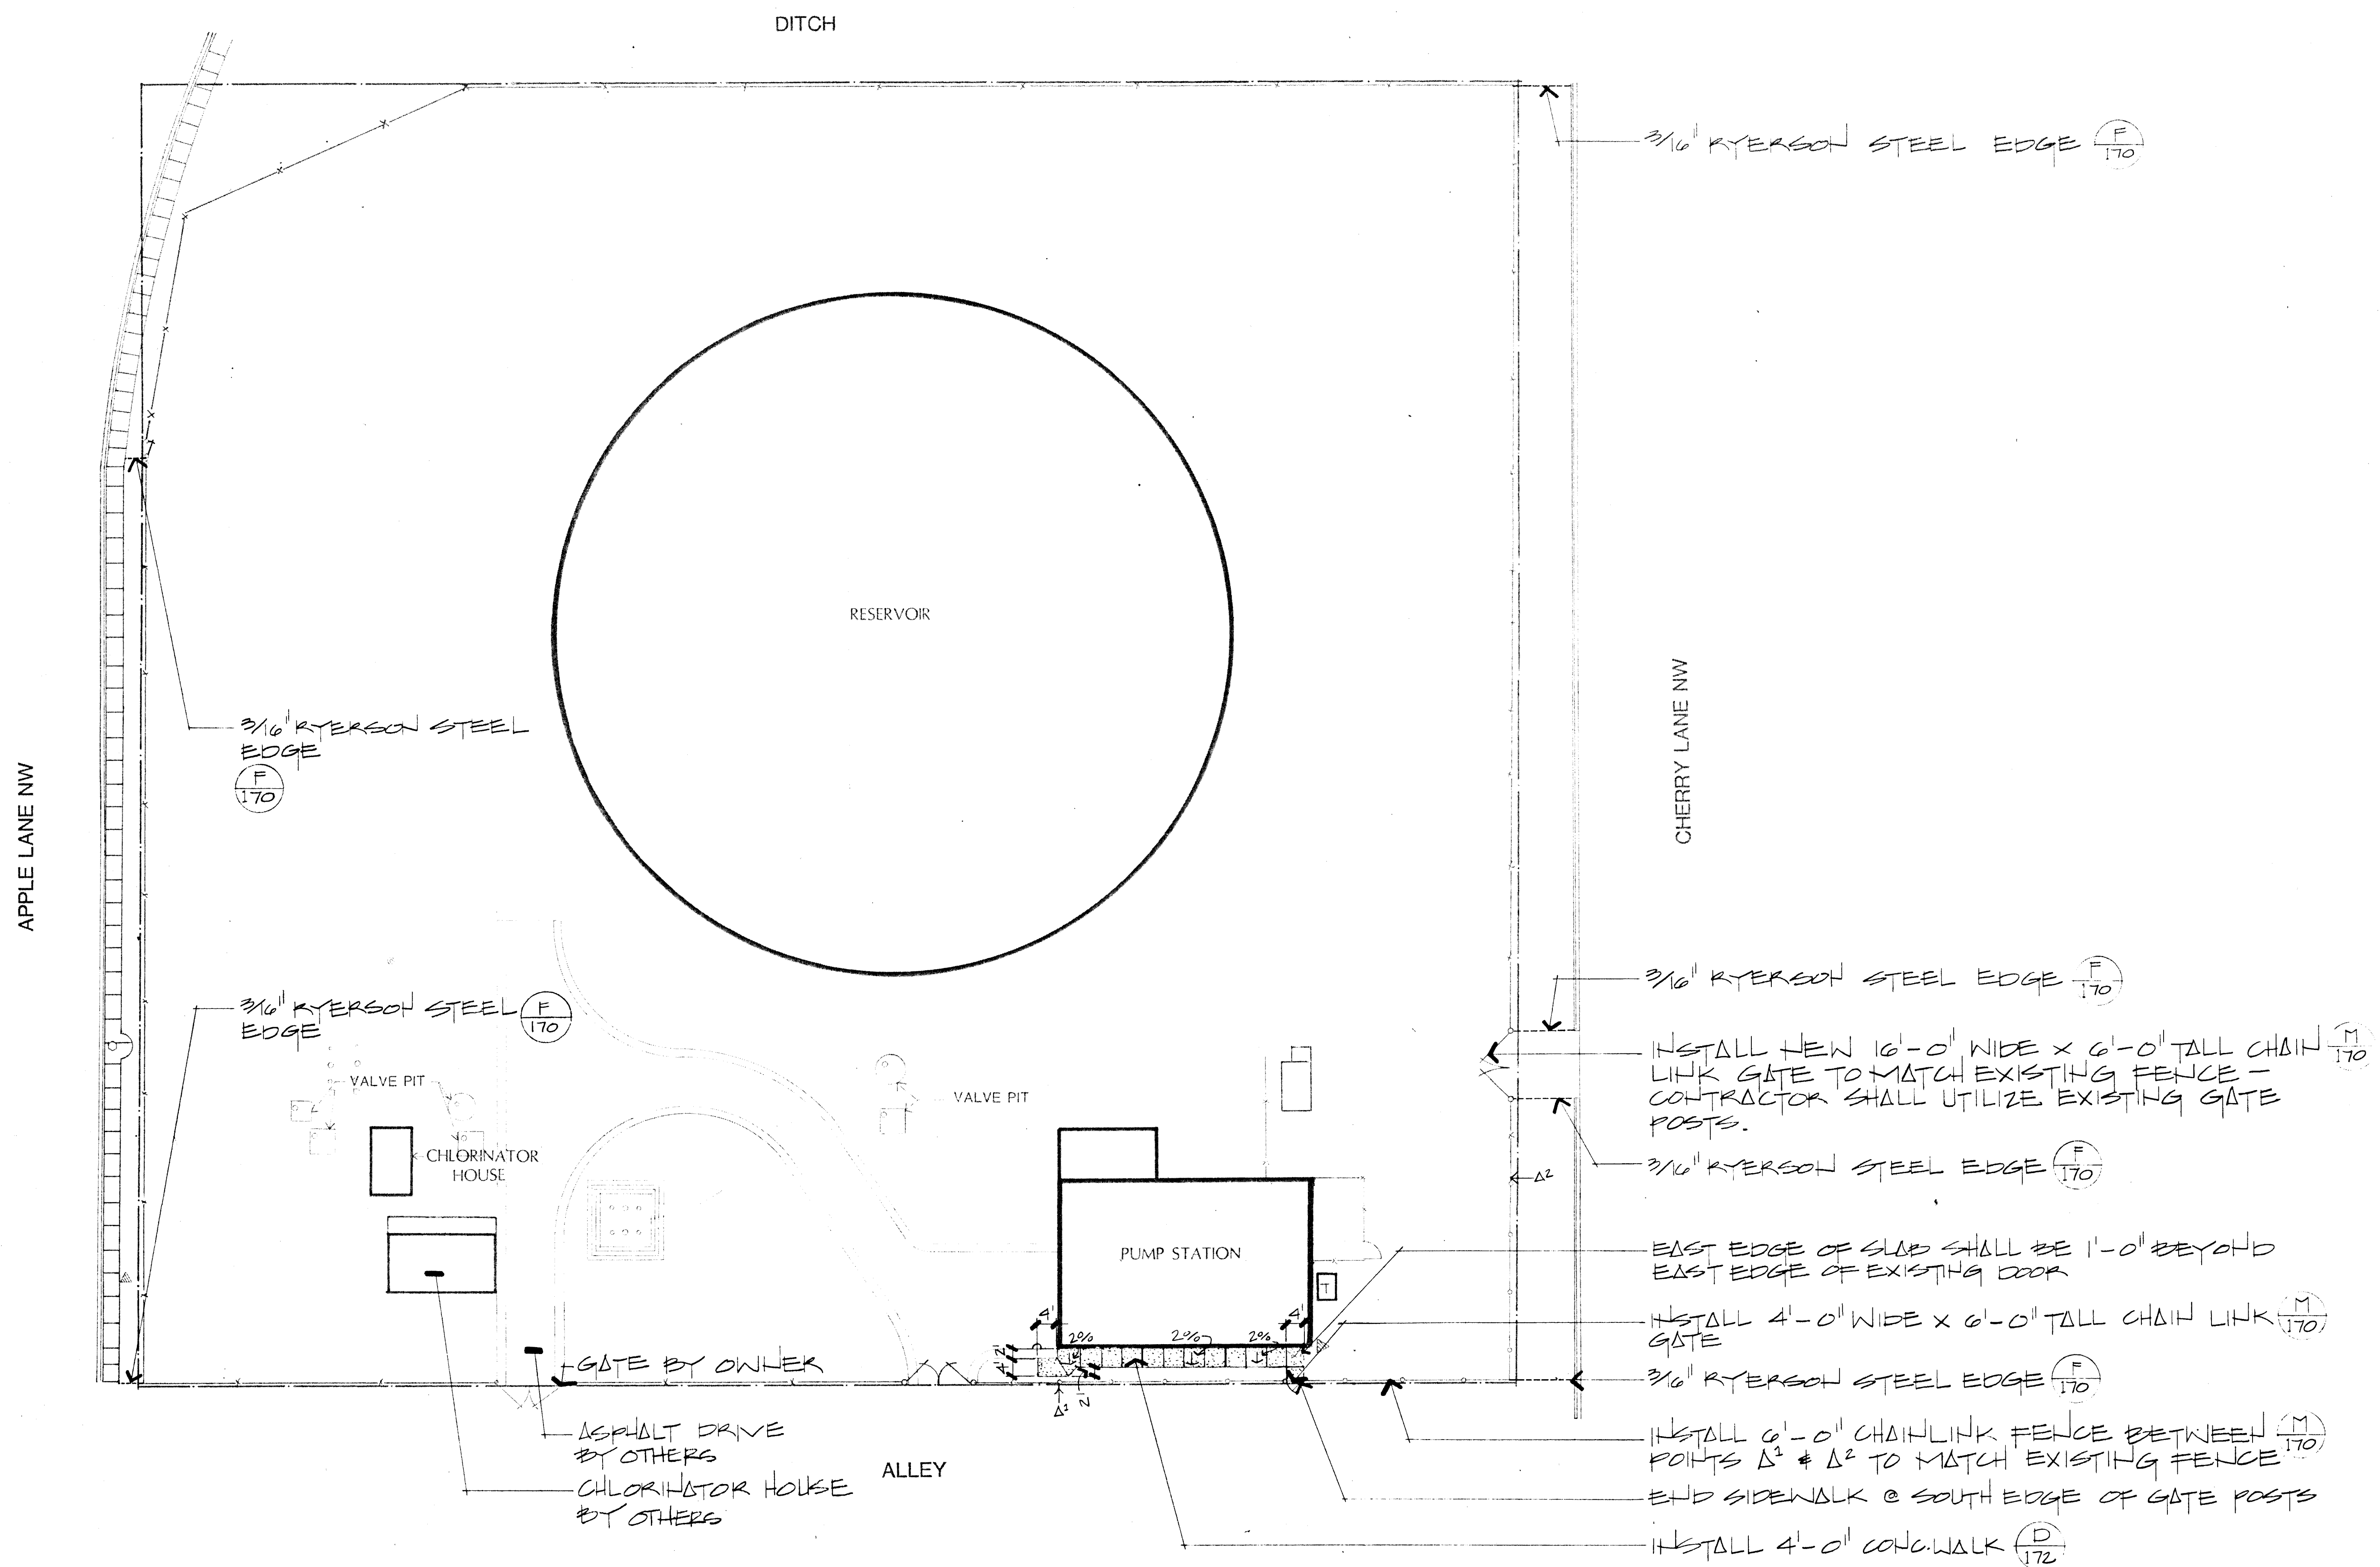



NOTE:
New chlorine facilities and asphalt paving may be under construction (by others -
NIC) during the construction of the landscape improvements described herein. The
Contractor shall coordinate all proposed landscape demolition and construction
with the on-going construction of the chlorine facilities and asphalt paving. The
Contractor shall notify the Landscape Architect of any problems that may occur
concerning the coordination of the two projects.

NOTE:
CONTRACTOR MAY FENCE PORTIONS OF
EXISTING FENCE AS APPROPRIATE. EX-
ISTING FENCE THAT IS DAMAGED IN ANY
WAY SHALL NOT BE RELEASD.

SCALE 1"=20'-0"
0 10 20 40

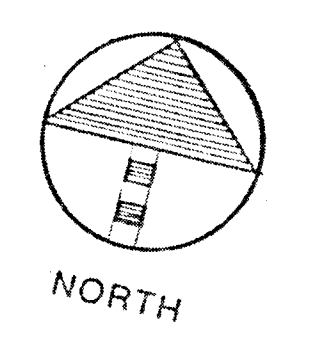


26 3097 2186

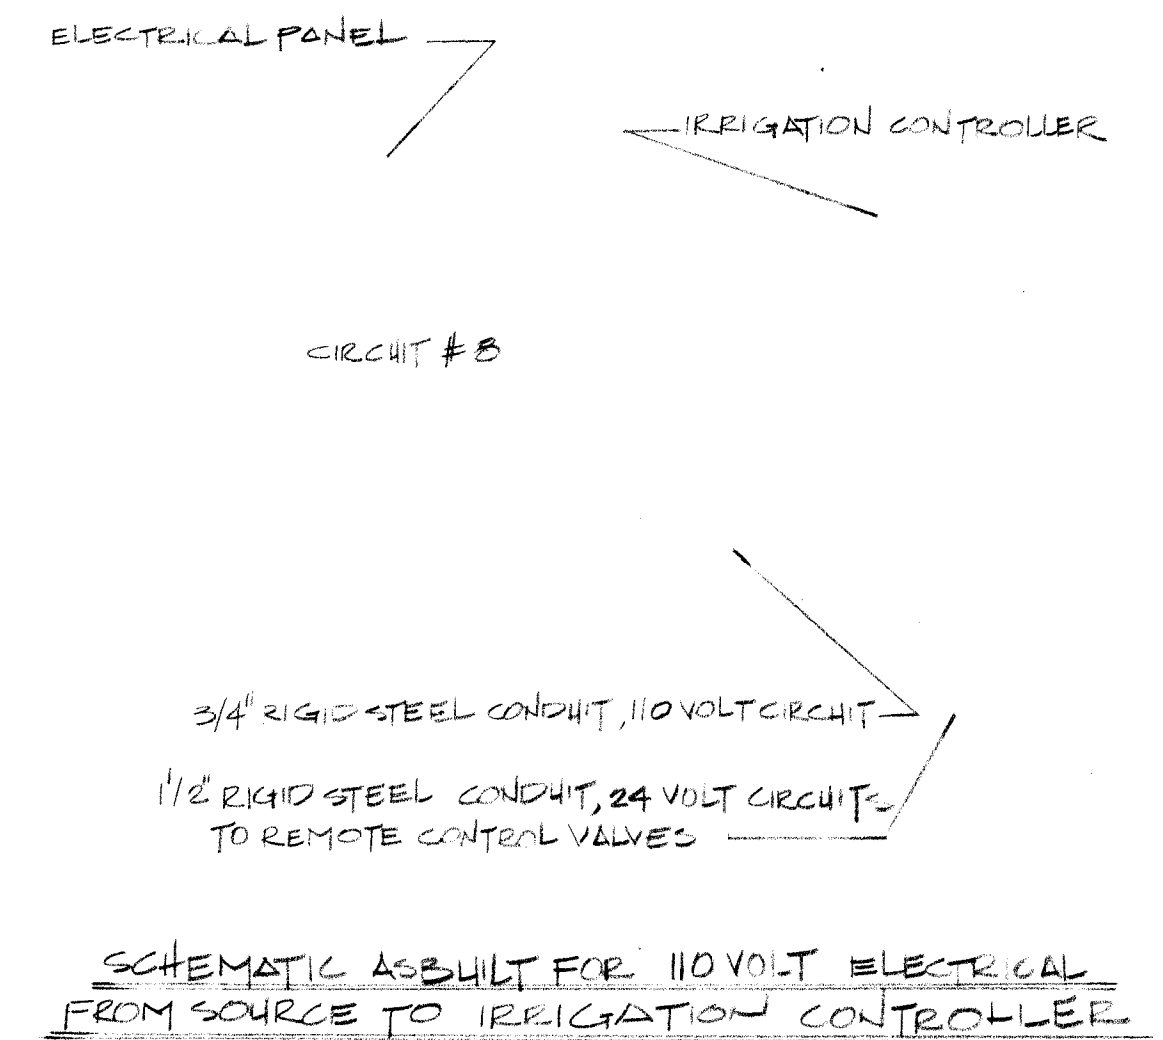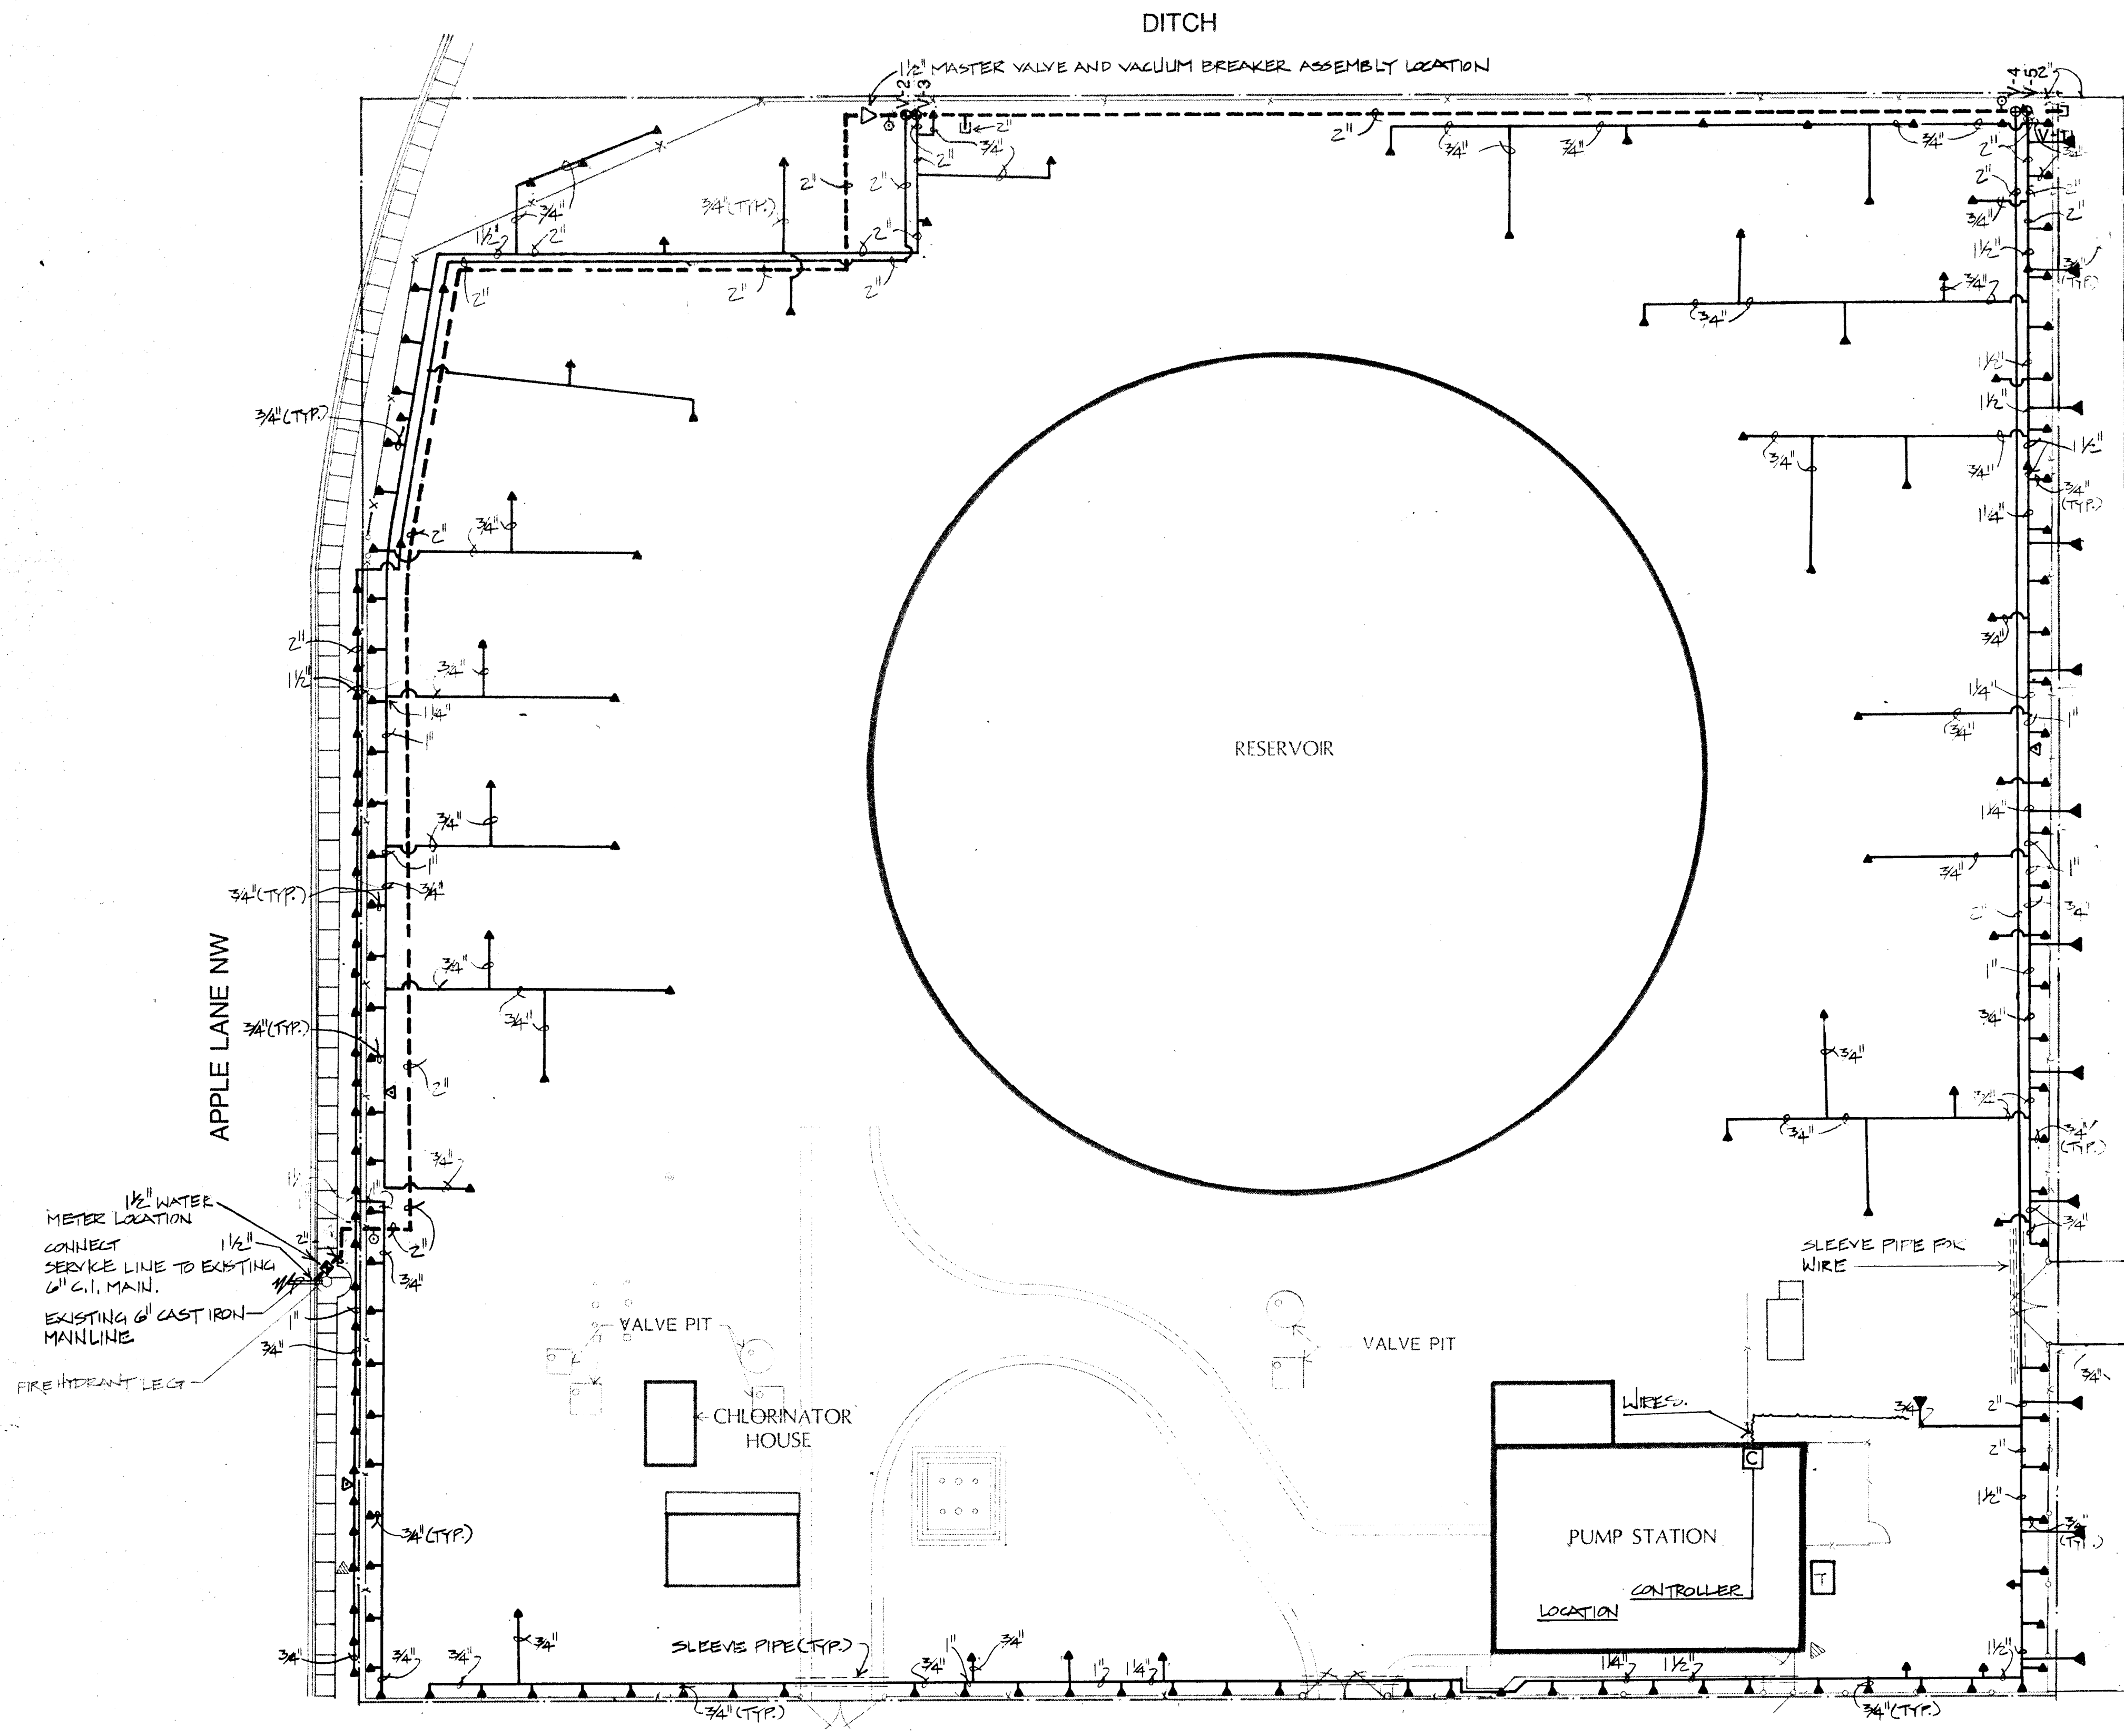


SCALE 1"=20'-0"


0 10 20 40

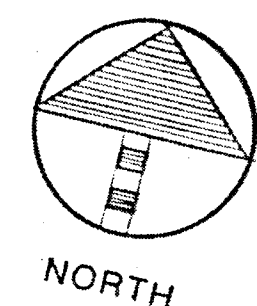

26 30.97 228.6

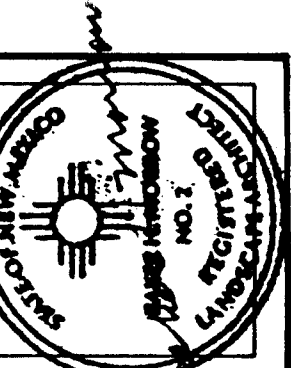

MORROW & COMPANY
LANDSCAPE ARCHITECTS
210 La Veta Drive NE
Albuquerque, New Mexico 87108
505-268-2266

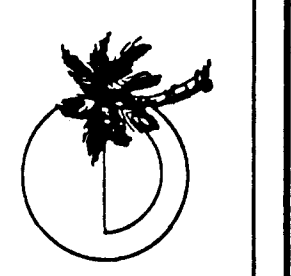


NOVEMBER
1986

AS BUILT

DURANES RESERVOIR & PUMP STATION
1917 CHERRY LANE NW
IRRIGATION PLAN

LANDSCAPING IMPROVEMENTS FOR
WATER SYSTEM FACILITY SITES
WATER SYSTEMS DIVISION
CITY OF ALBUQUERQUE
ALBUQUERQUE, NEW MEXICO


SHEET
22
OF
172

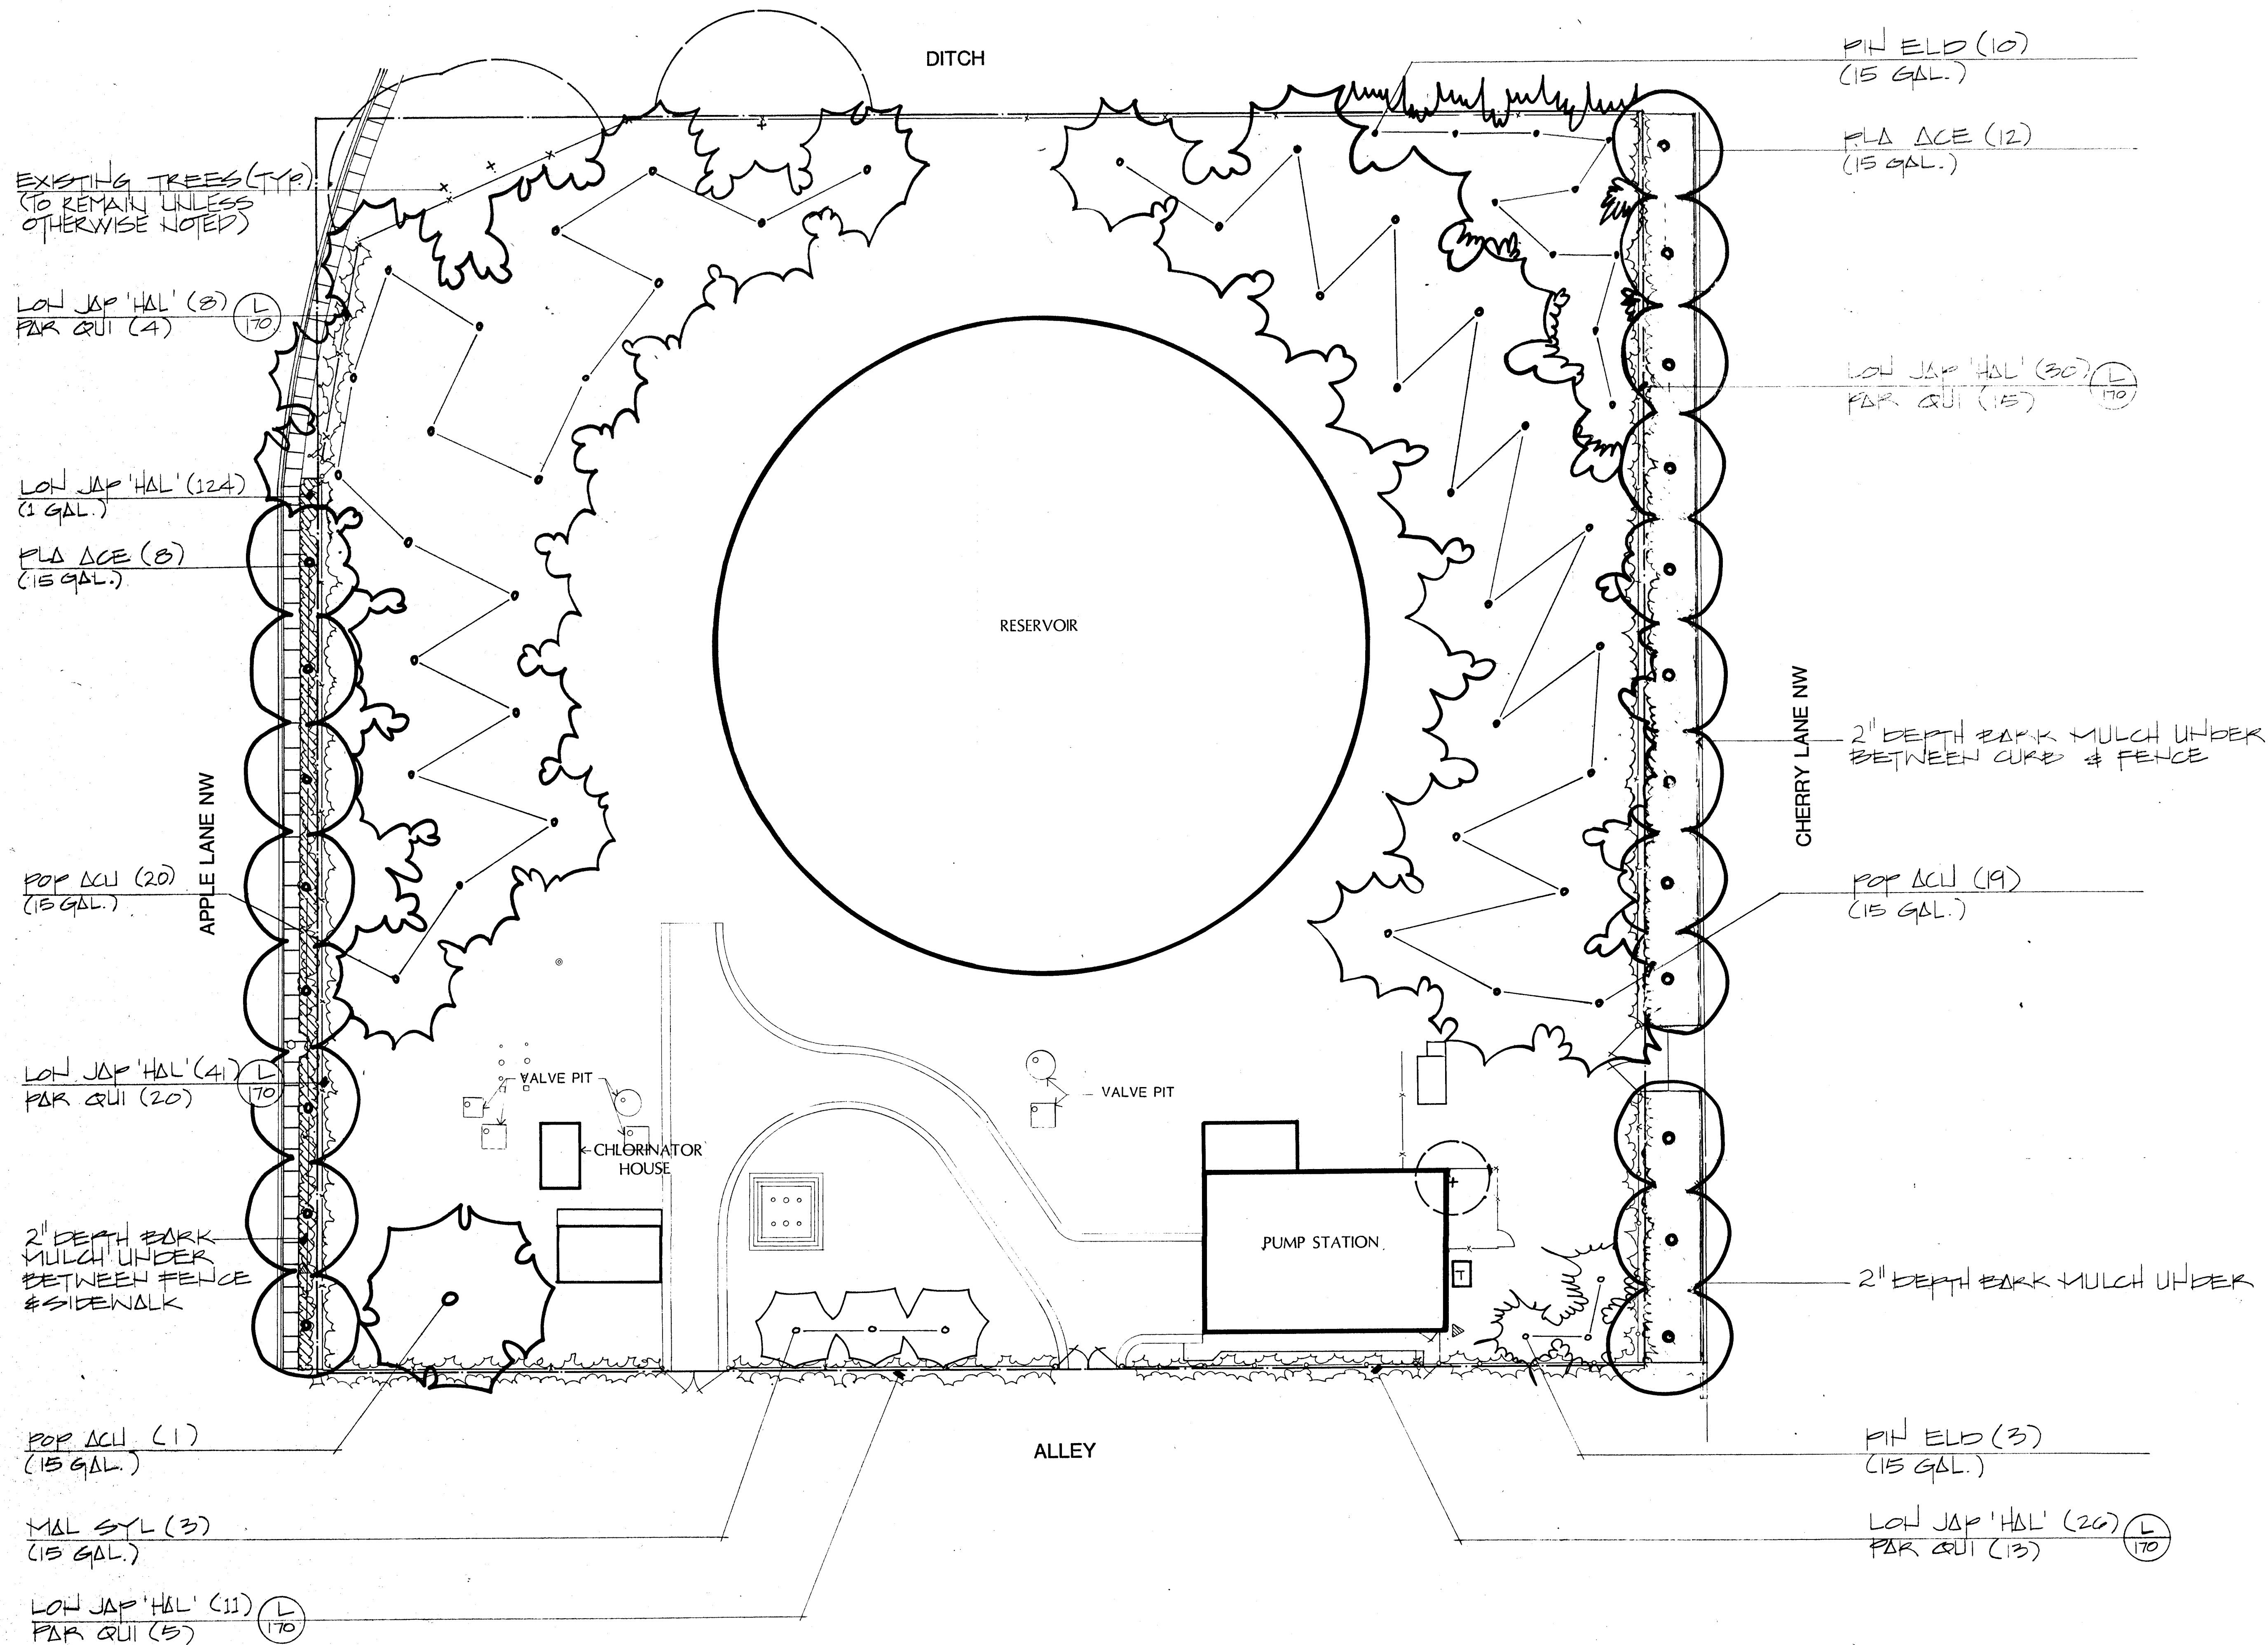


NOTE:
New chlorine facilities and asphalt paving may be under construction (by others - NIC) during the construction of the landscape improvements described herein. The Contractor shall coordinate all proposed landscape demolition and construction with the on-going construction of the chlorine facilities and asphalt paving. The Contractor shall notify the Landscape Architect of any problems that may occur concerning the coordination of the two projects.

SCALE 1"=20'-0"


0 10 20 40

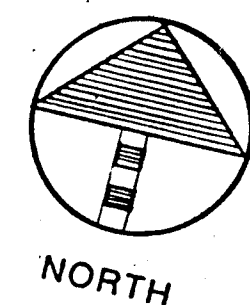

26 3097 2386

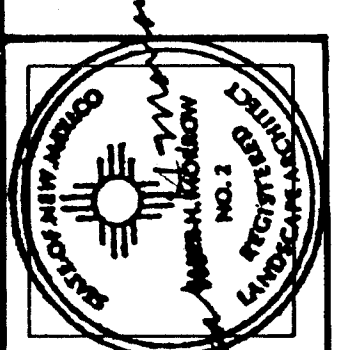

MORROW & COMPANY
LANDSCAPE ARCHITECTS
210 La Veta Drive NE
Albuquerque, New Mexico 87108
505-268-2266

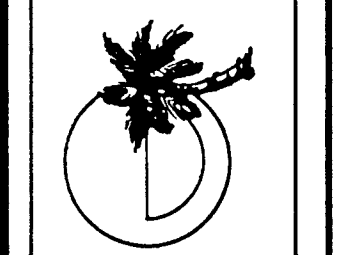


NOVEMBER
1986

DURANES RESERVOIR & PUMP STATION
1917 CHERRY LANE NW
PLANTING PLAN
AS BUILT

LANDSCAPING IMPROVEMENTS FOR
WATER SYSTEM FACILITY SITES
WATER SYSTEMS DIVISION
CITY OF ALBUQUERQUE
ALBUQUERQUE, NEW MEXICO


SHEET
23
OF
172

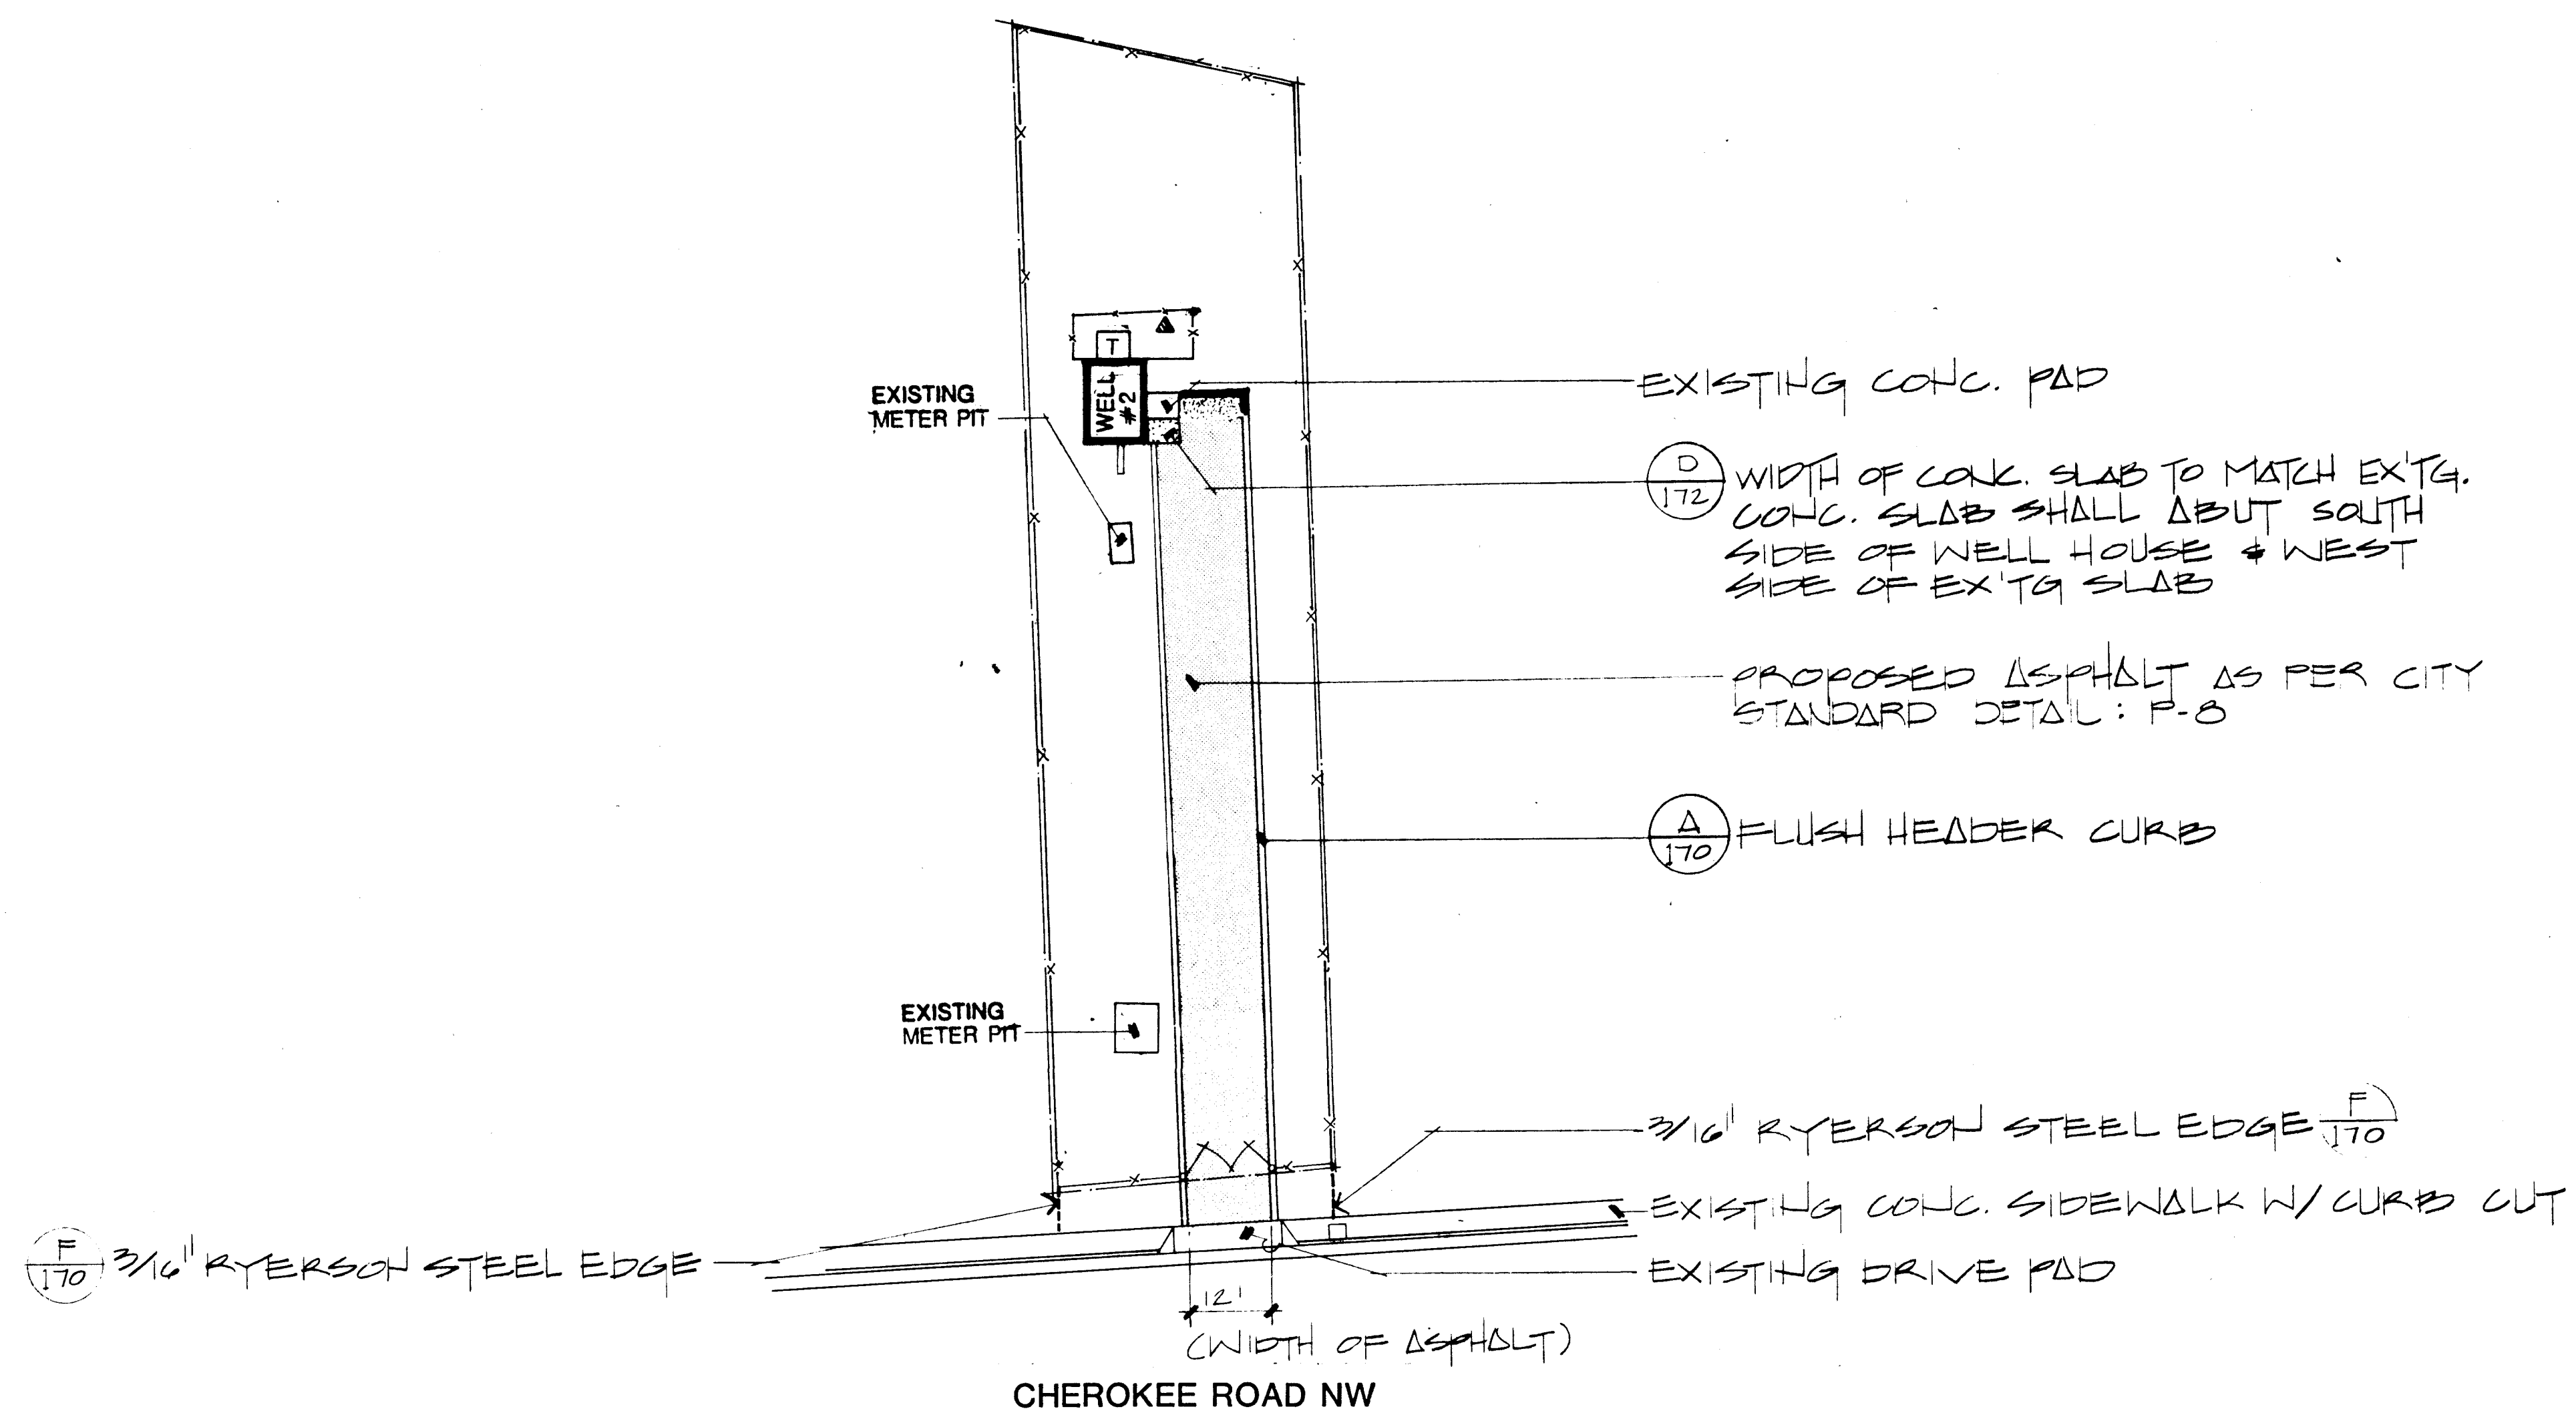

AS BUILT

SCALE 1"=20'-0"

0 10 20 40

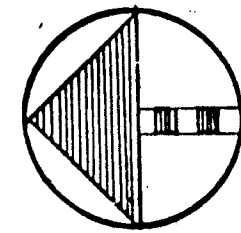


MORROW & COMPANY
LANDSCAPE ARCHITECTS
210 La Veta Drive NE
Albuquerque, New Mexico 87108
505-268-2266

NOVEMBER
1986

GREIGOS WELL #2
1954 CHEROKEE ROAD NW
CONSTRUCTION PLAN

LANDSCAPING IMPROVEMENTS FOR
WATER SYSTEM FACILITY SITES
WATER SYSTEMS DIVISION
CITY OF ALBUQUERQUE
ALBUQUERQUE, NEW MEXICO

SHEET
20
172

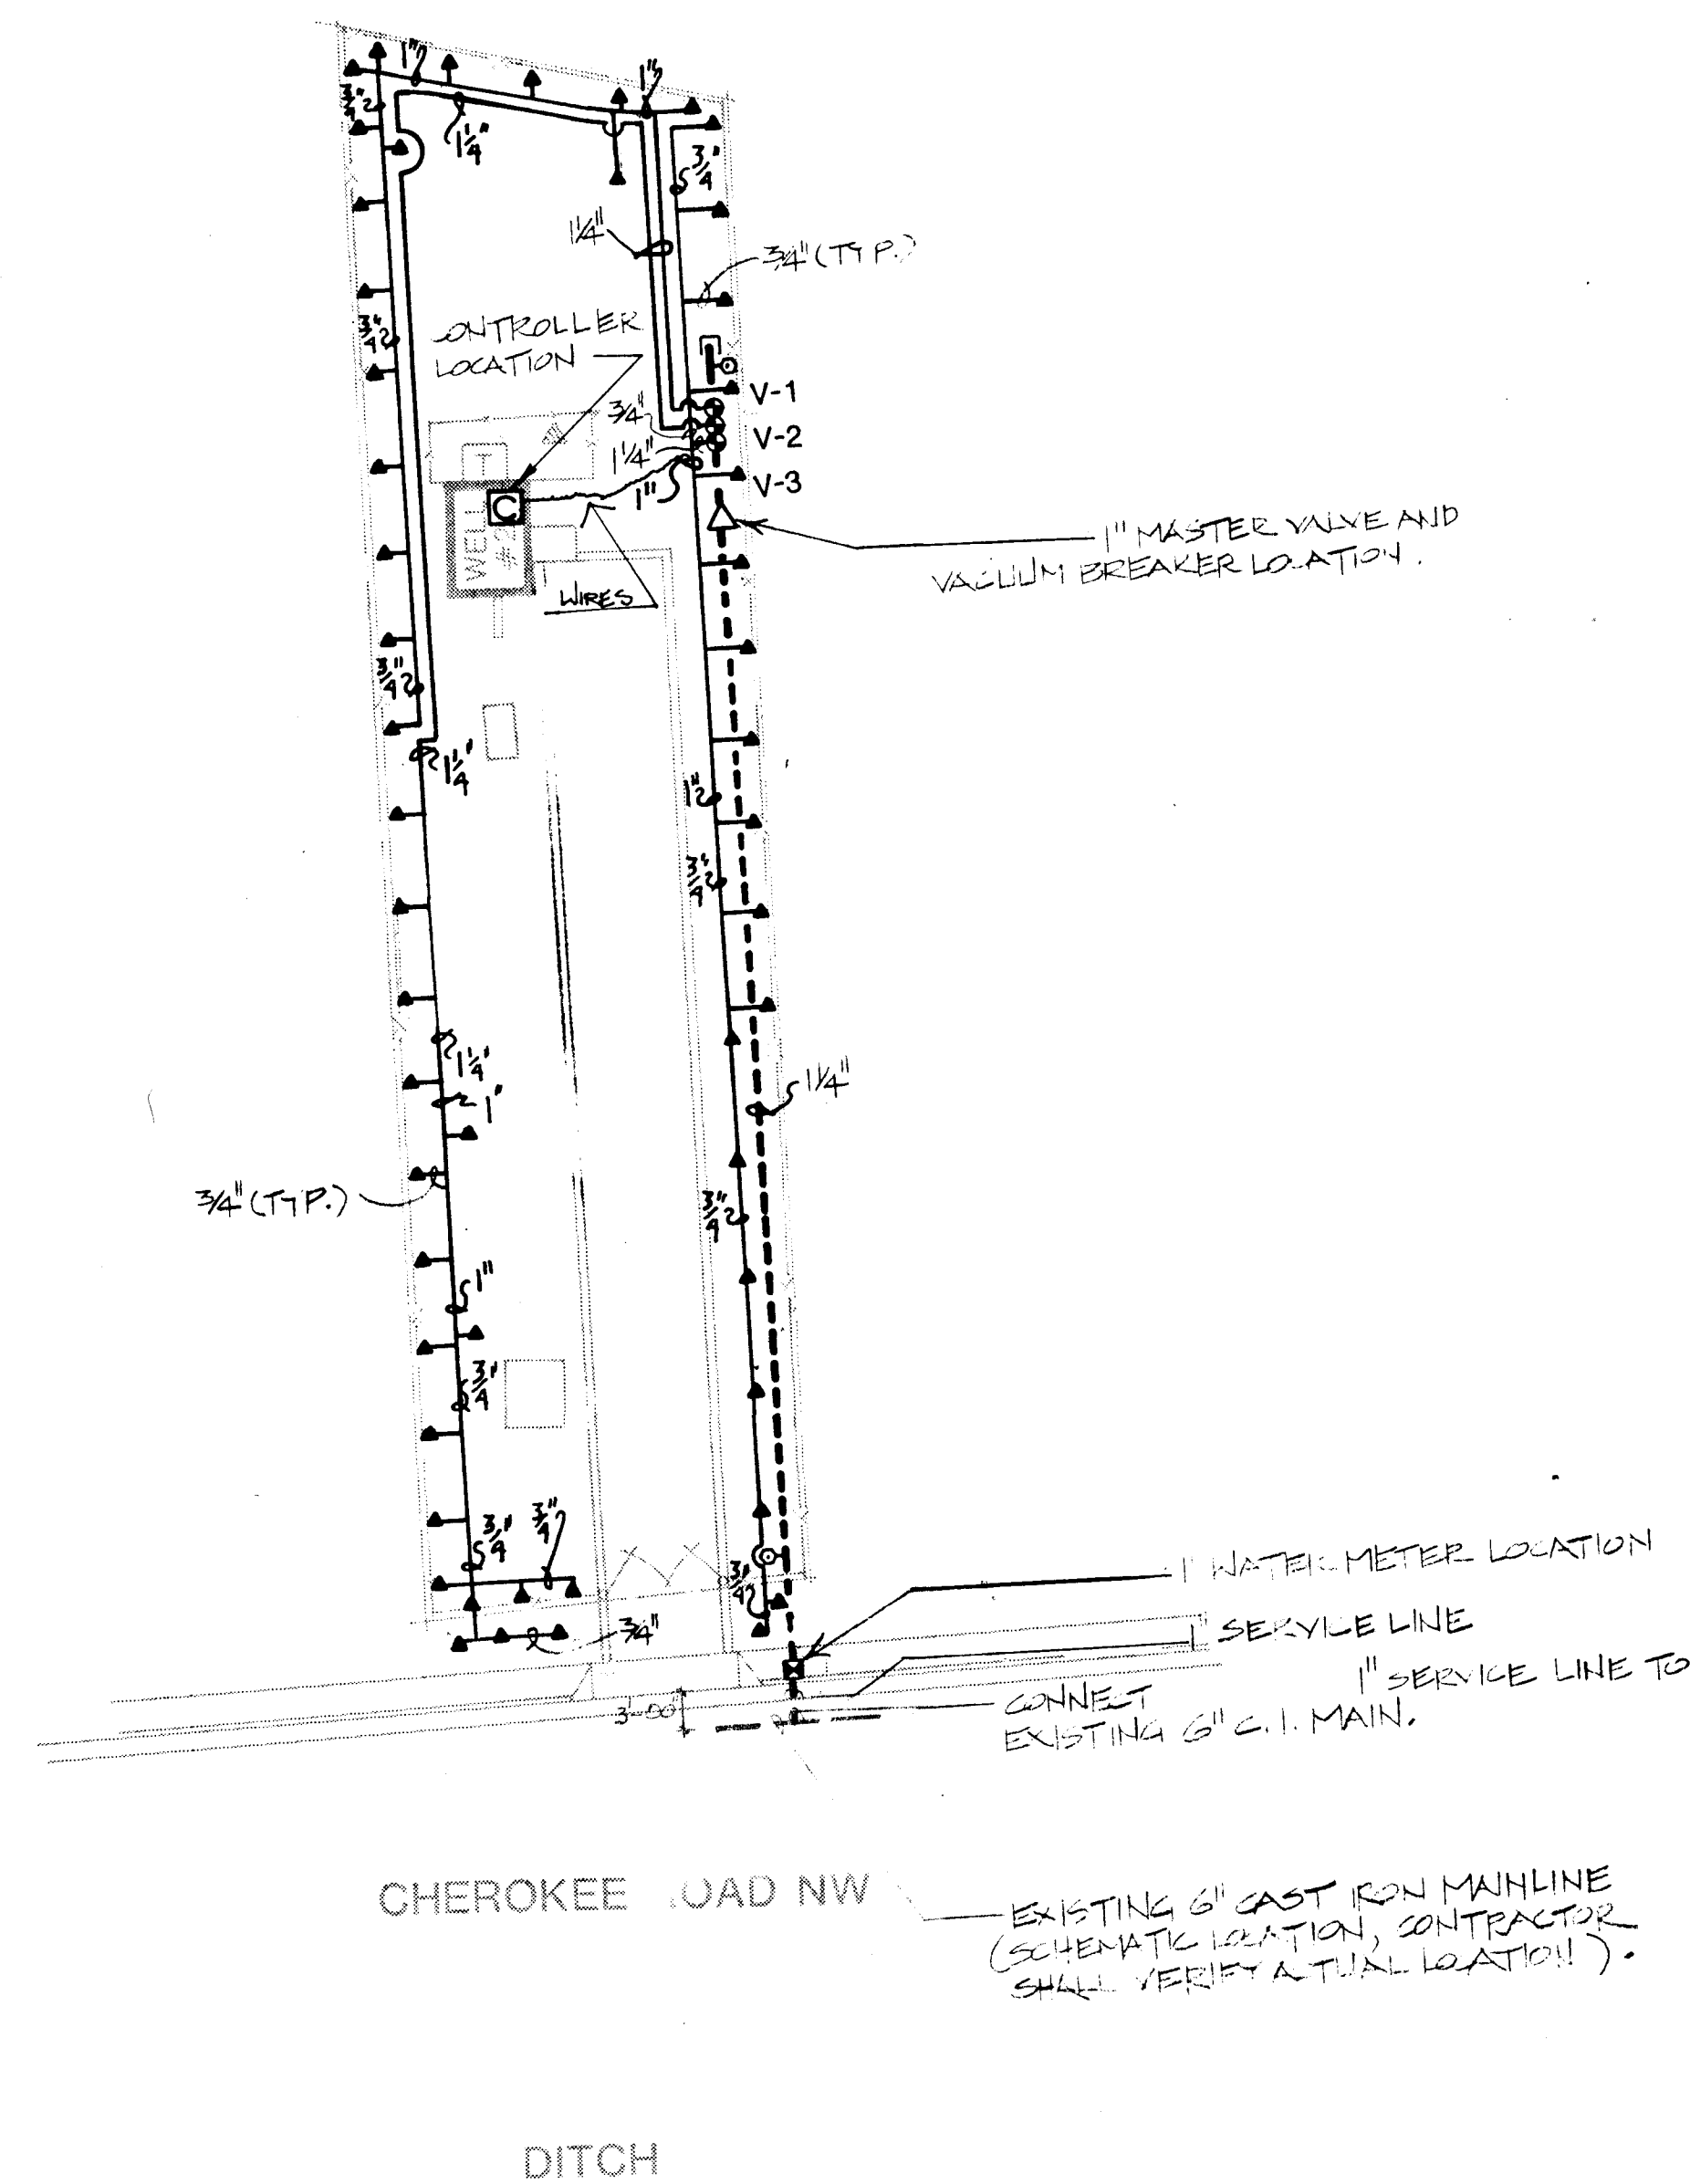

ELECTRICAL PANEL —

IRIGATION CONTROLLER

CIRCUIT #2

3/4" RIGID STEEL CONDUIT, 110VOLT CIRCUIT


1/2" RIGID STEEL CONDUIT, 24-VOLT CIRCUITS TO REMOTE CONTROL VALVES

SCHEMATIC AS BUILT FOR 110 VOLT ELECTRICAL FROM SOURCE TO IRRIGATION CONTROLLER

26 3097 2686

SCALE 1"=20'-0"

0 10 20 40

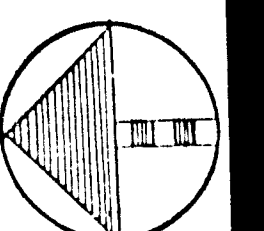

MORROW & COMPANY
LANDSCAPE ARCHITECTS
210 La Veta Drive NE
Albuquerque, New Mexico 87108
505-268-2266


NOVEMBER
1986

AS BUILT

GREIGOS WELL #2
1954 CHEROKEE ROAD NW
IRRIGATION PLAN



LANDSCAPING IMPROVEMENTS FOR
WATER SYSTEM FACILITY SITES
WATER SYSTEMS DIVISION
CITY OF ALBUQUERQUE
ALBUQUERQUE, NEW MEXICO

SHEET
24
OF
172

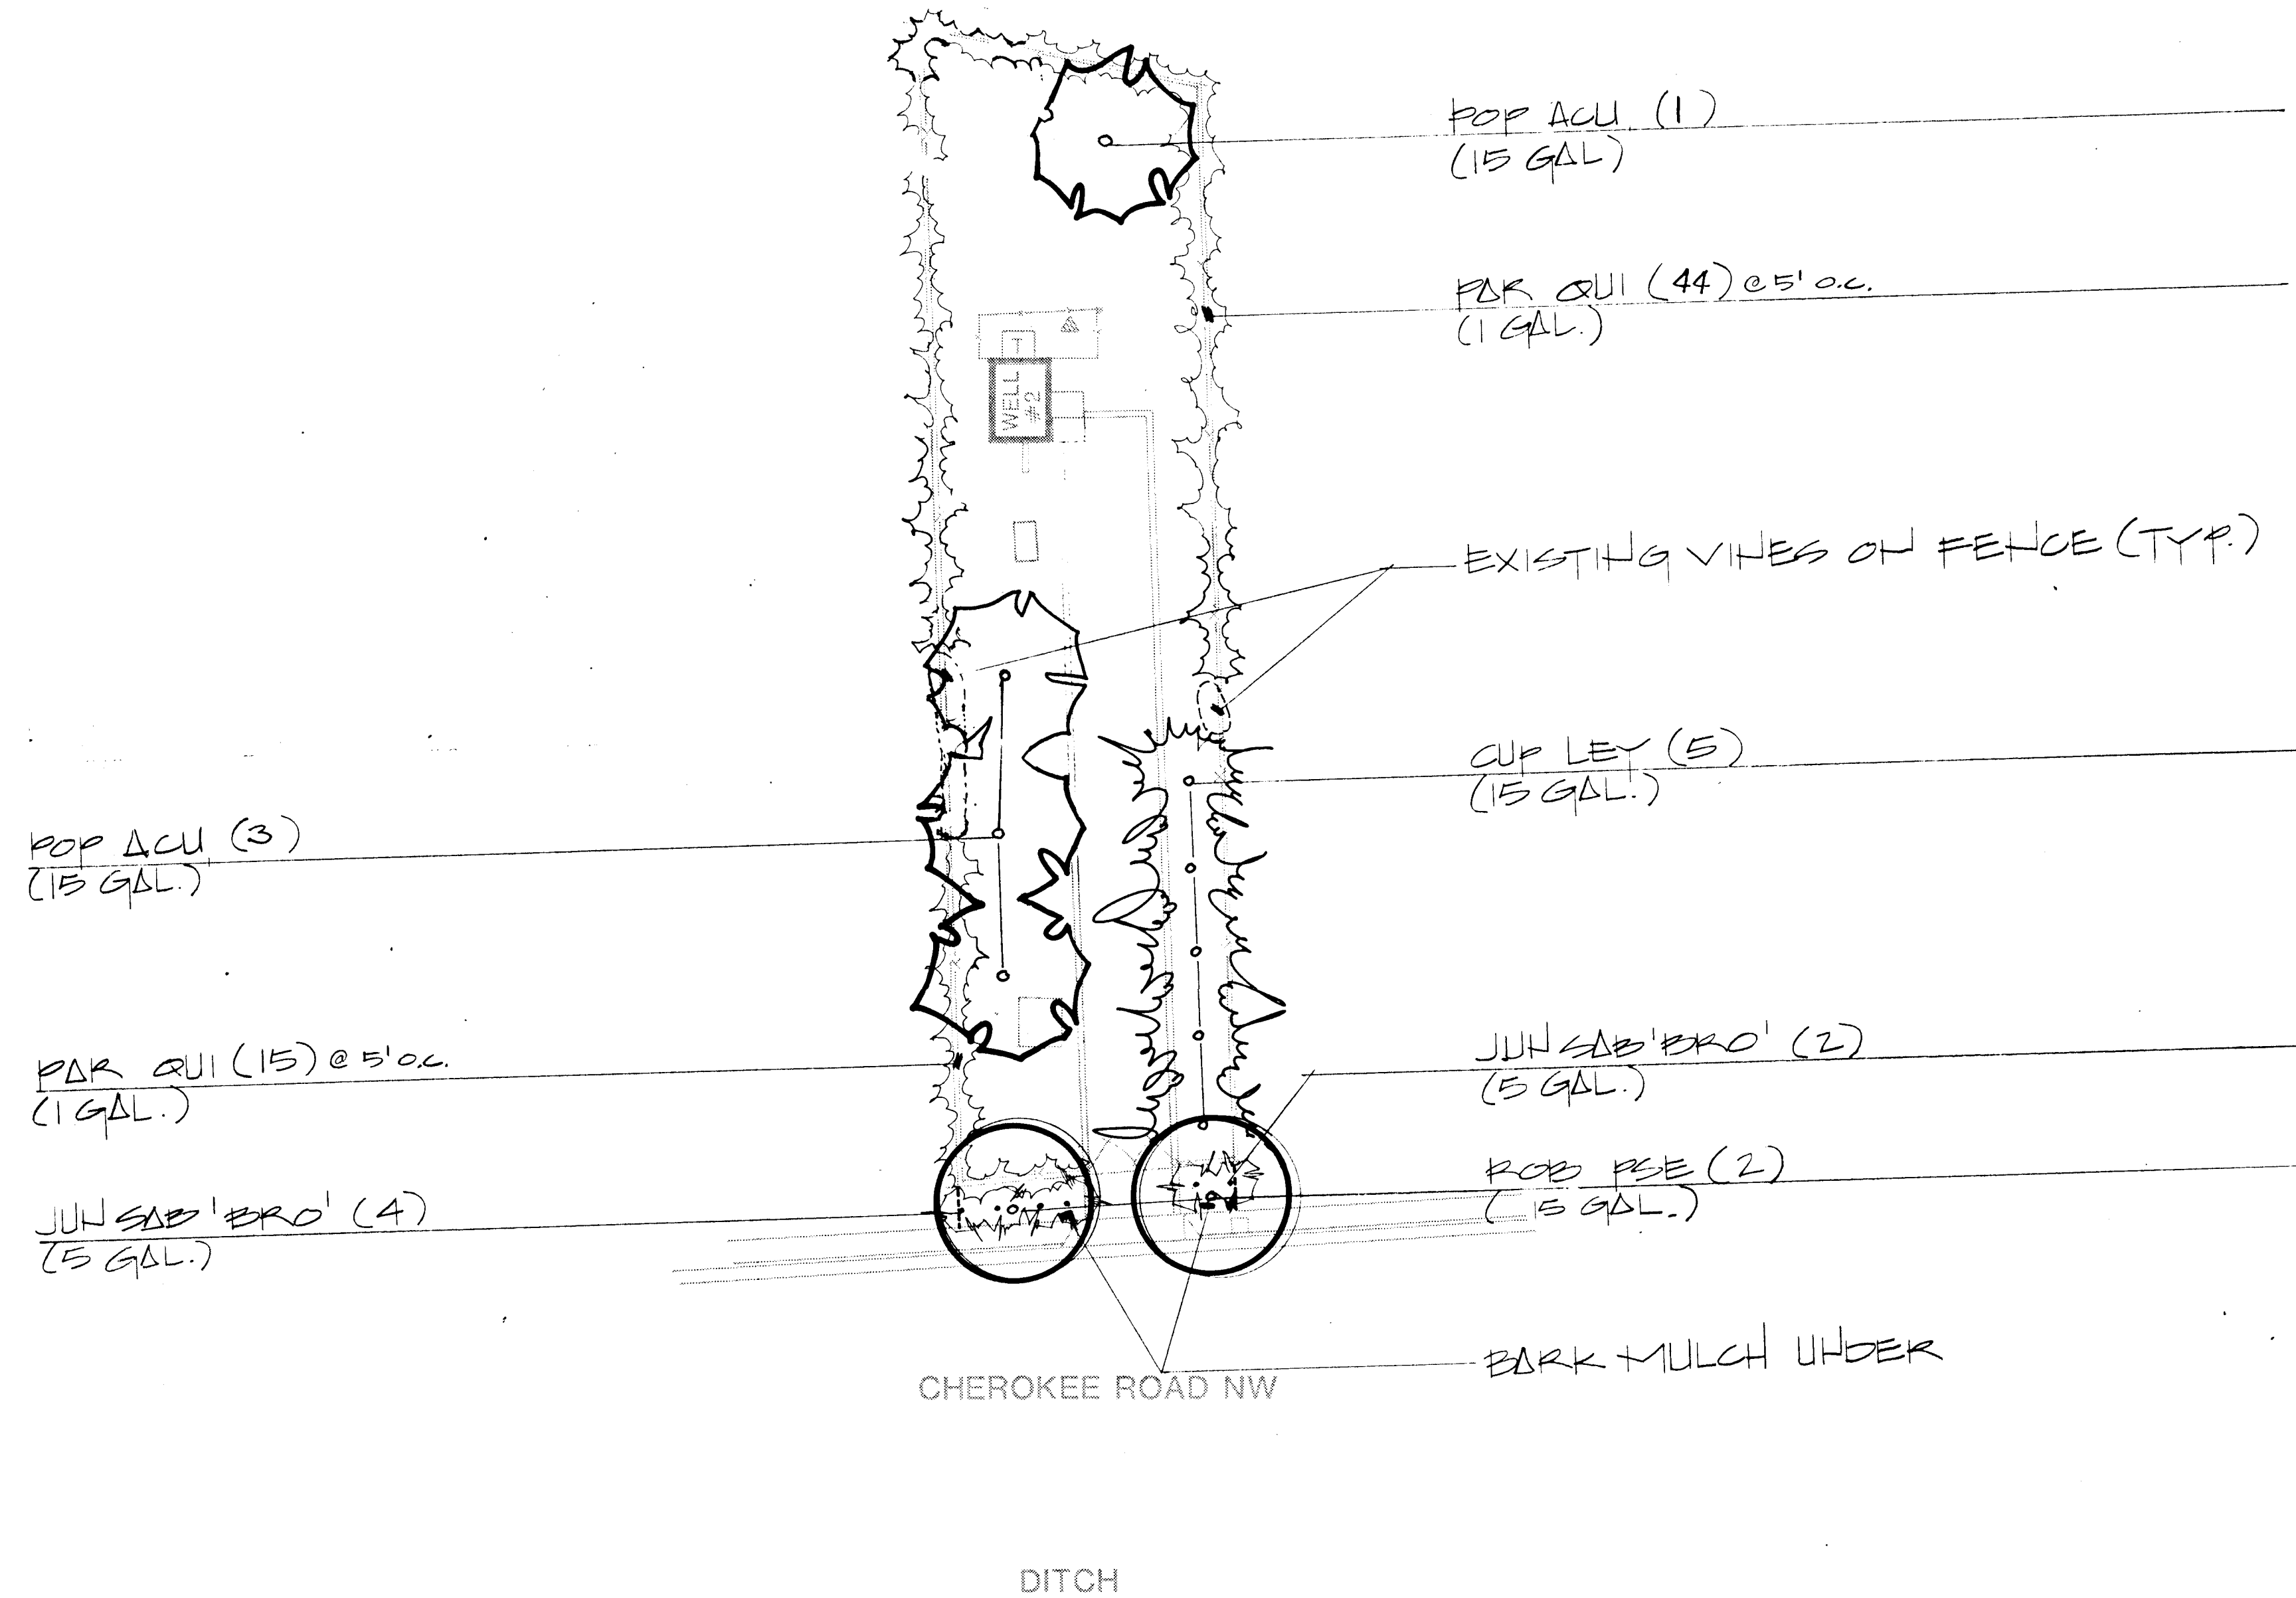


26 3097 2786

SCALE 1"=20'-0"
0 10 20 40

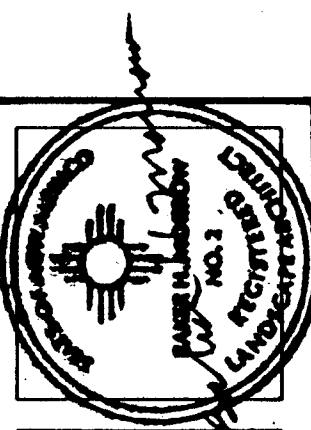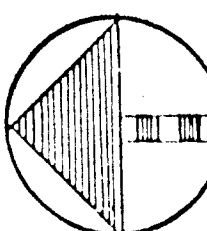

MORROW & COMPANY
LANDSCAPE ARCHITECTS
210 La Veta Drive NE
Albuquerque, New Mexico 87108
505-268-2266

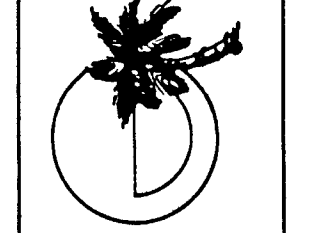


NOVEMBER
1986

AS BUILT

GREIGOS WELL #2
1954 CHEROKEE ROAD NW
PLANTING PLAN


LANDSCAPING IMPROVEMENTS FOR
WATER SYSTEM FACILITY SITES
WATER SYSTEMS DIVISION
CITY OF ALBUQUERQUE
ALBUQUERQUE, NEW MEXICO

SHEET
88
172

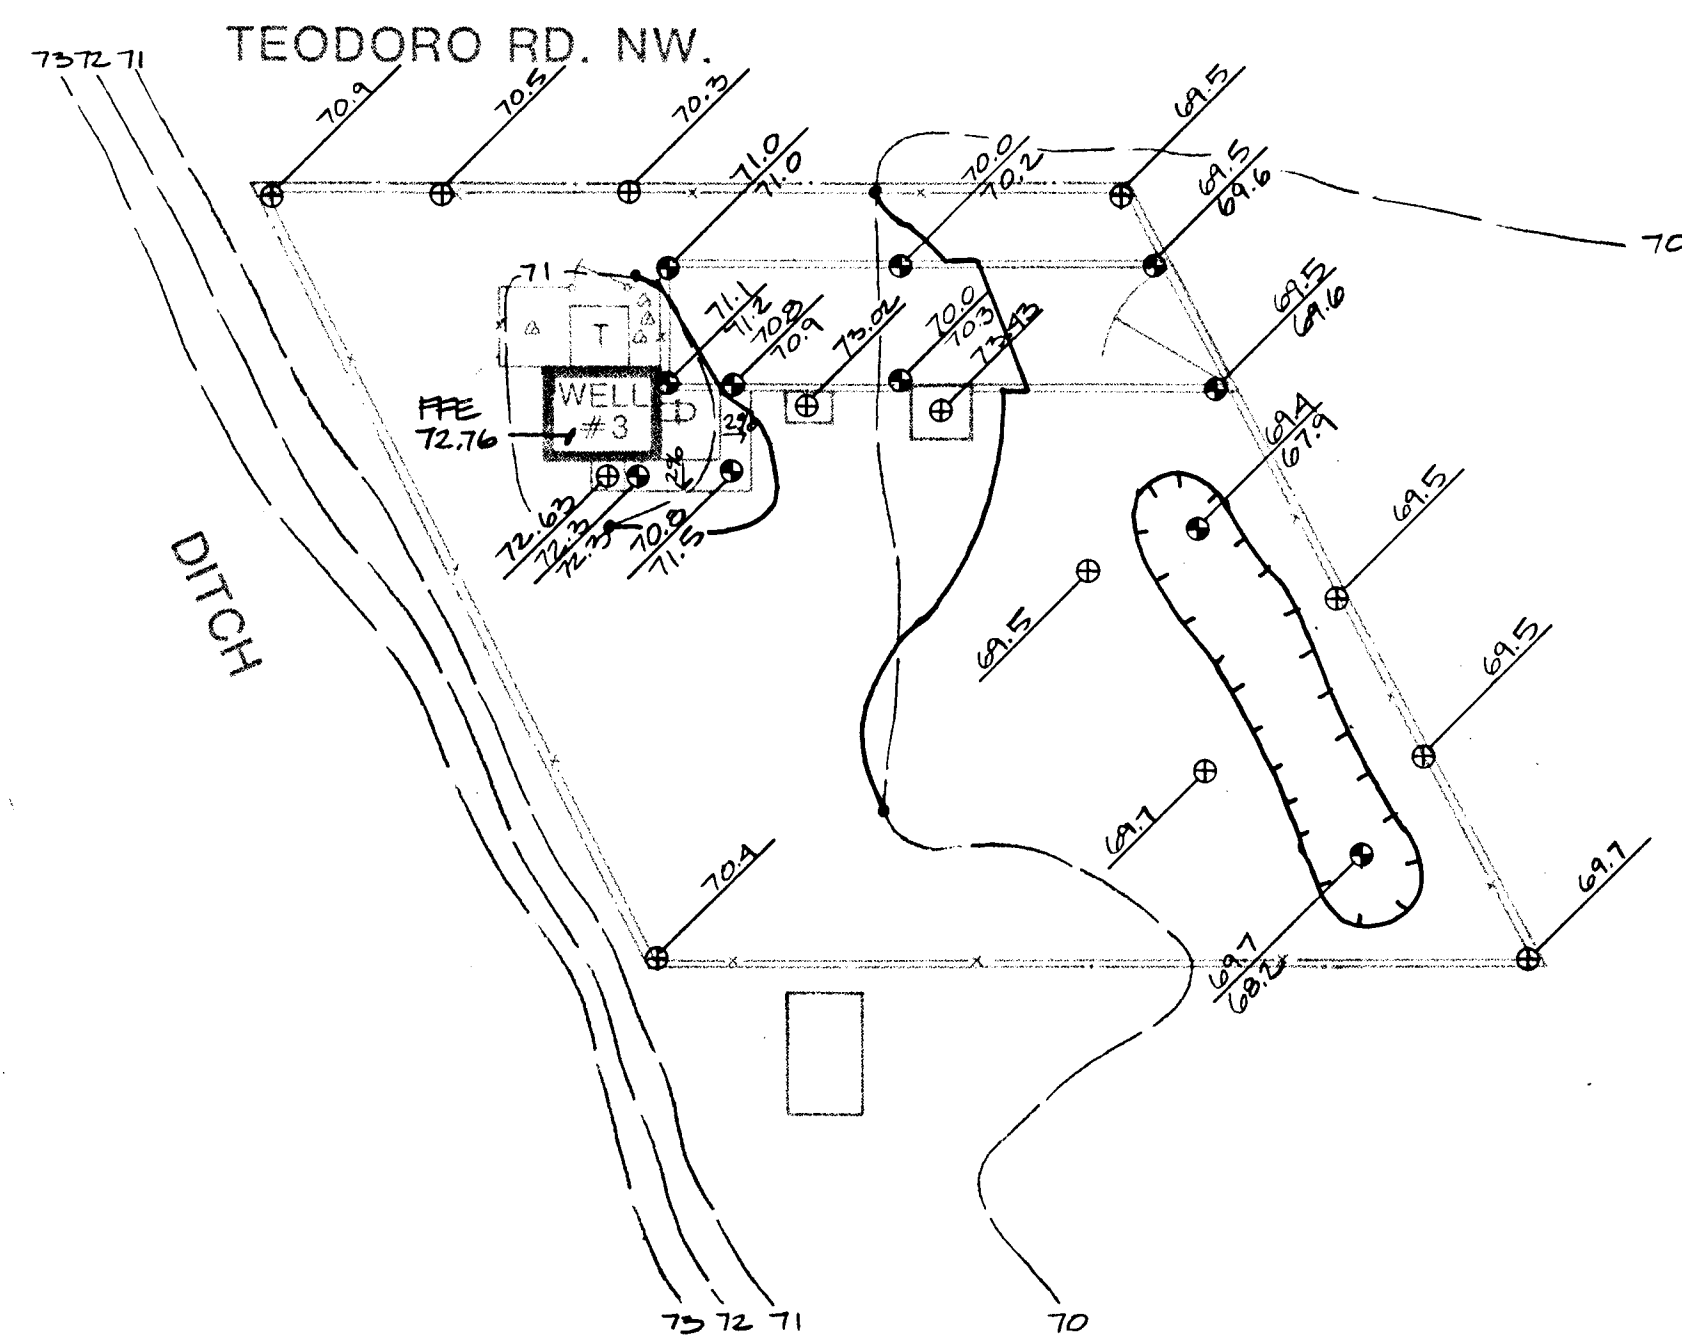

26 3097 2886

SCALE 1"=20'-0"

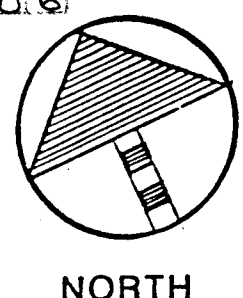


SHEET
3
172

LANDSCAPING IMPROVEMENTS FOR
WATER SYSTEM FACILITY SITES
WATER SYSTEMS DIVISION
CITY OF ALBUQUERQUE
ALBUQUERQUE, NEW MEXICO


GRIEGOS WELL #3
2322 TEODORO ROAD NW
GRADING PLAN


AS BUILT

NOVEMBER
1986

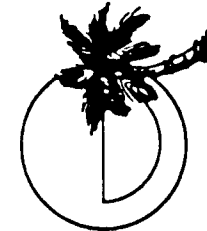

MORROW & COMPANY
LANDSCAPE ARCHITECTS
210 La Veta Drive NE
Albuquerque, New Mexico 87108
505-268-2266

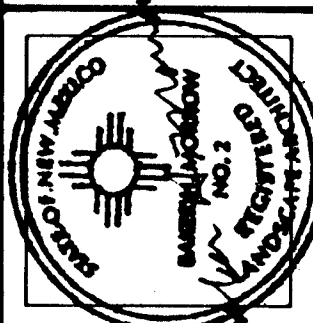


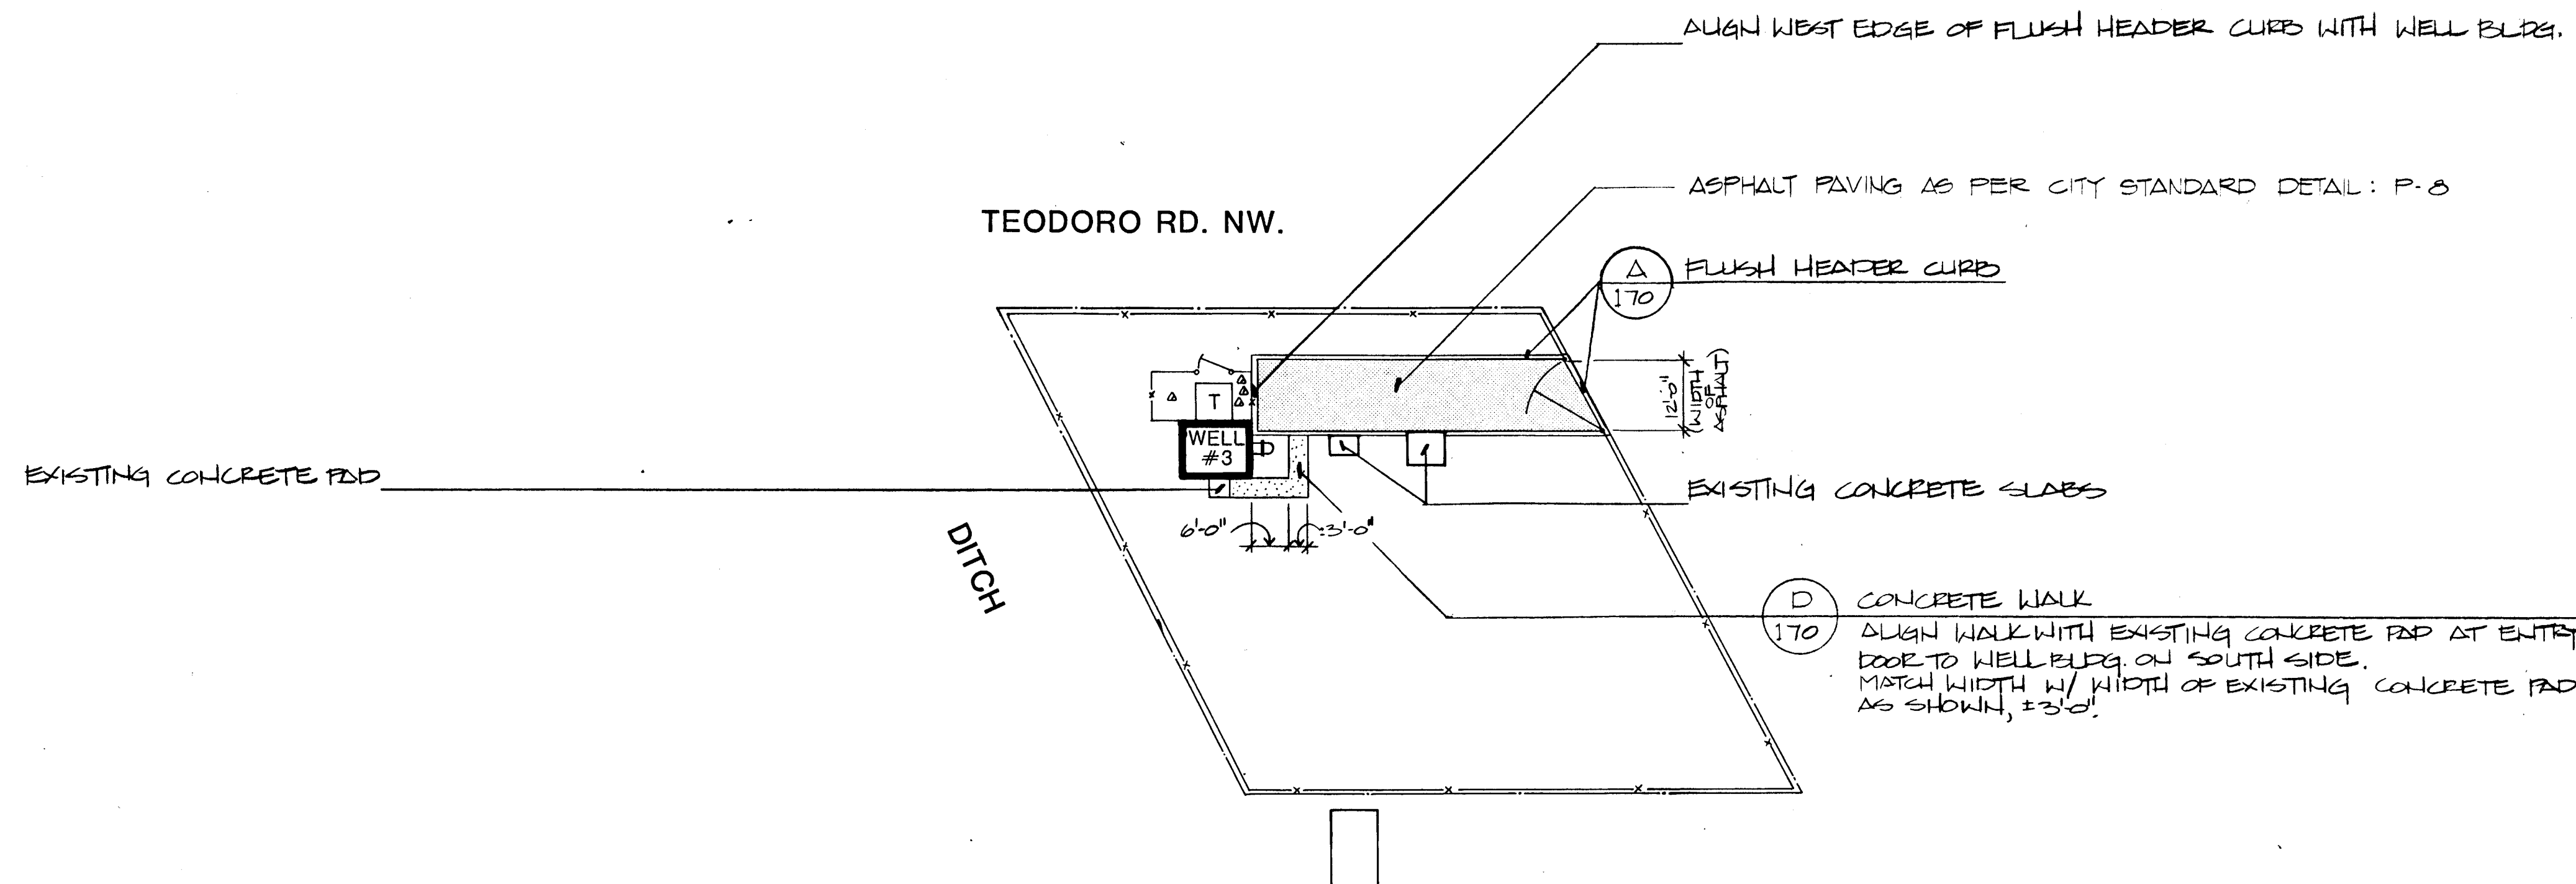

26 3097 2986

SCALE 1"=20'-0"

0 10 20 40

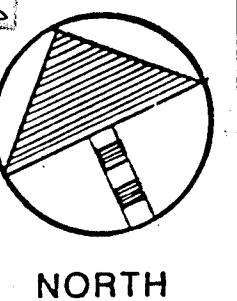

MORROW & COMPANY
LANDSCAPE ARCHITECTS
210 La Veta Drive NE
Albuquerque, New Mexico 87108
505-268-2266


NOVEMBER
1986

AS BUILT

GRIEGOS WELL #3
2322 TEODORO ROAD NW
CONSTRUCTION PLAN

LANDSCAPING IMPROVEMENTS FOR
WATER SYSTEM FACILITY SITES
WATER SYSTEMS DIVISION
CITY OF ALBUQUERQUE
ALBUQUERQUE, NEW MEXICO

SHEET
38
97
172

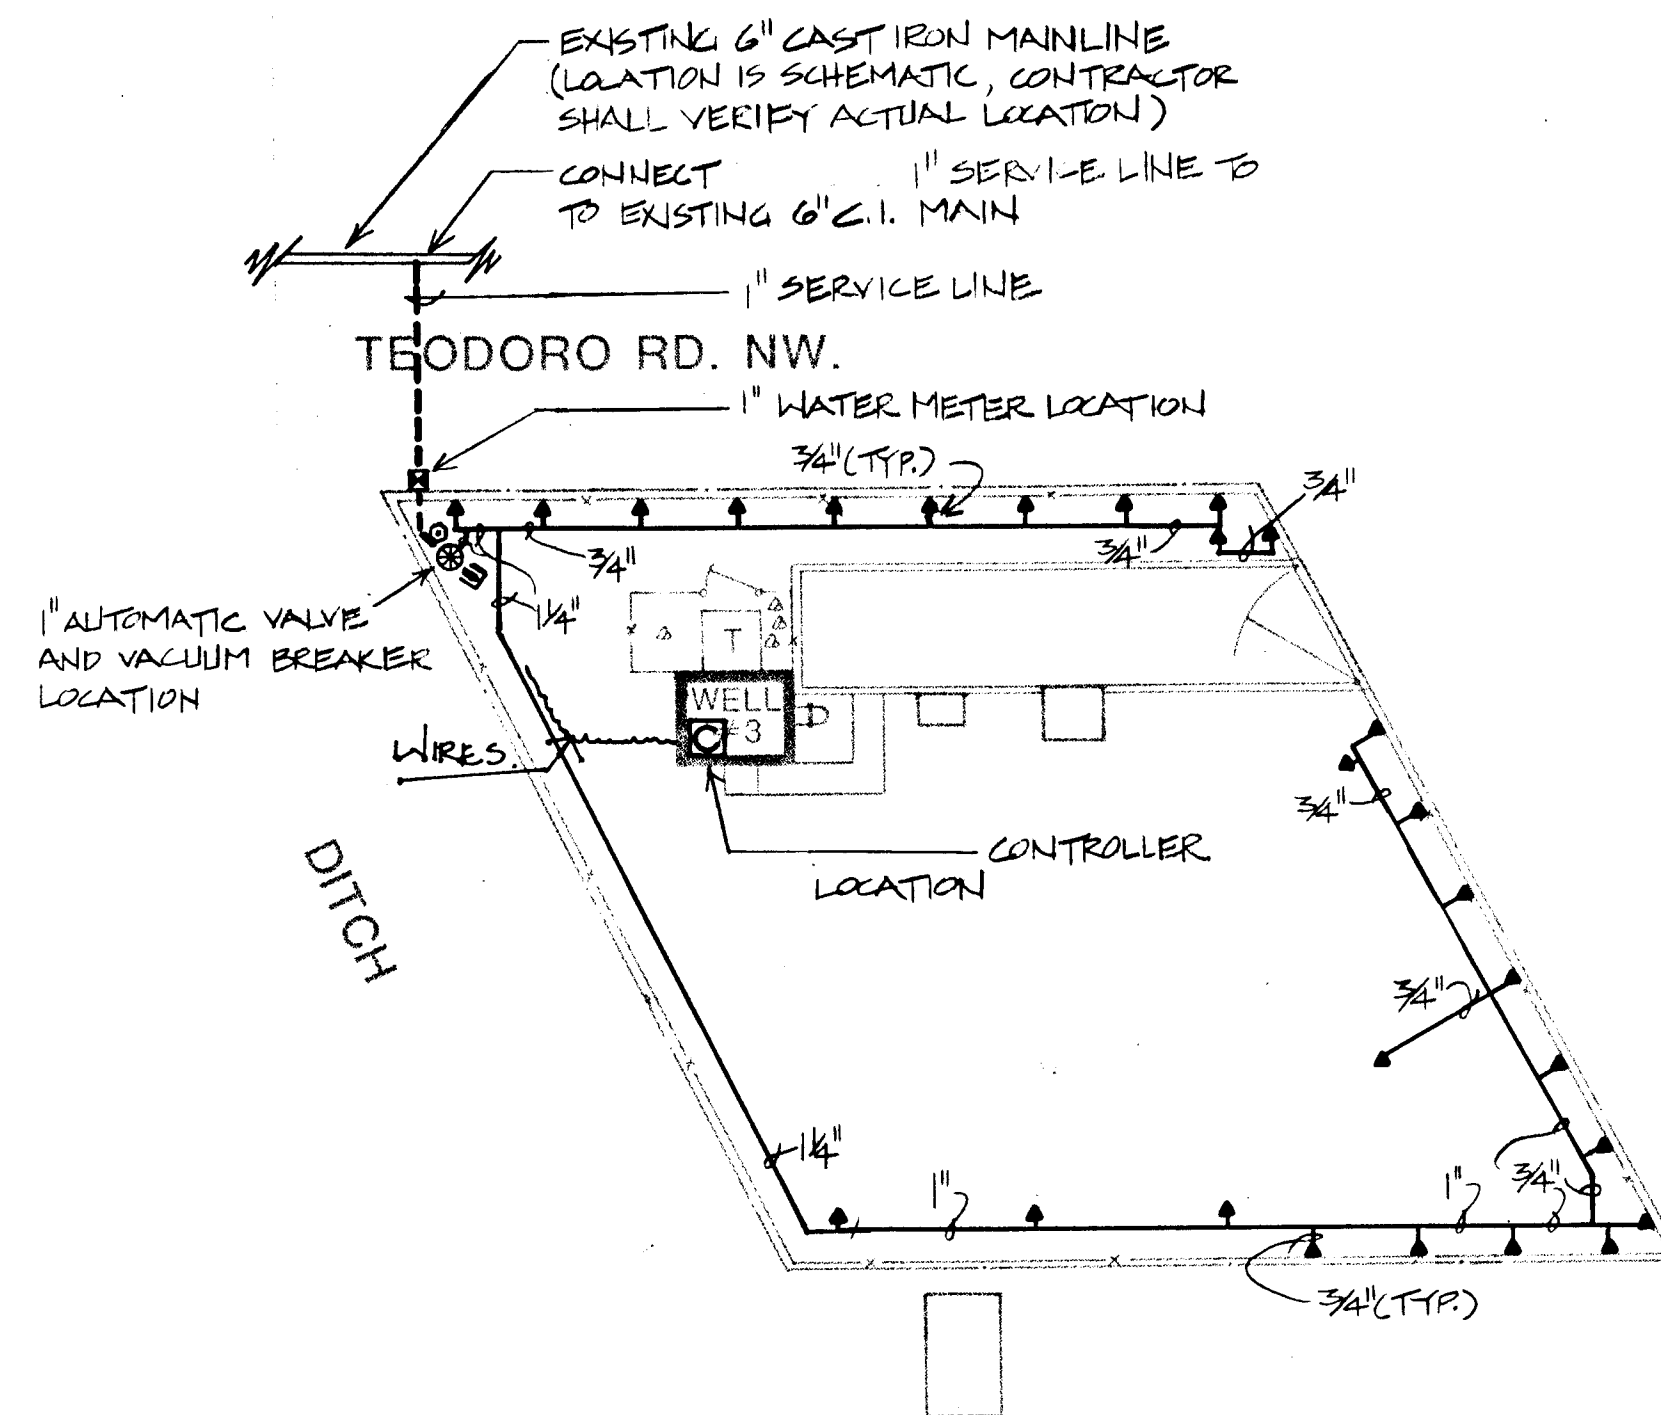

ELECTRICAL PANEL →

→ IRRIGATION CONTROLLER

CIRCUIT #1

3/4" RIGID STEEL CONDUIT, 110VOLT CIRCUIT →


1/2" RIGID STEEL CONDUIT, 24VOLT CIRCUITS TO REMOTE CONTROL VALVES →

SCHEMATIC AS-BUILT FOR 110VOLT ELECTRICAL FROM SOURCE TO IRRIGATION CONTROLLER.

26 3097 3086

SCALE 1"=20'-0"

0 10 20 40'

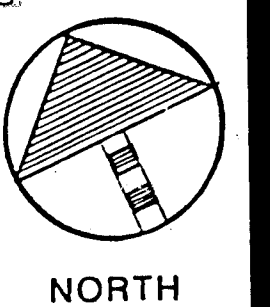

MORROW & COMPANY
LANDSCAPE ARCHITECTS
210 La Veta Drive NE
Albuquerque, New Mexico 87108
505-268-2266


NOVEMBER
1986

AS BUILT

GRIEGOS WELL #3
2322 TEODORO ROAD NW
IRRIGATION PLAN

LANDSCAPING IMPROVEMENTS FOR
WATER SYSTEM FACILITY SITES
WATER SYSTEMS DIVISION
CITY OF ALBUQUERQUE
ALBUQUERQUE, NEW MEXICO

SHEET
33
172

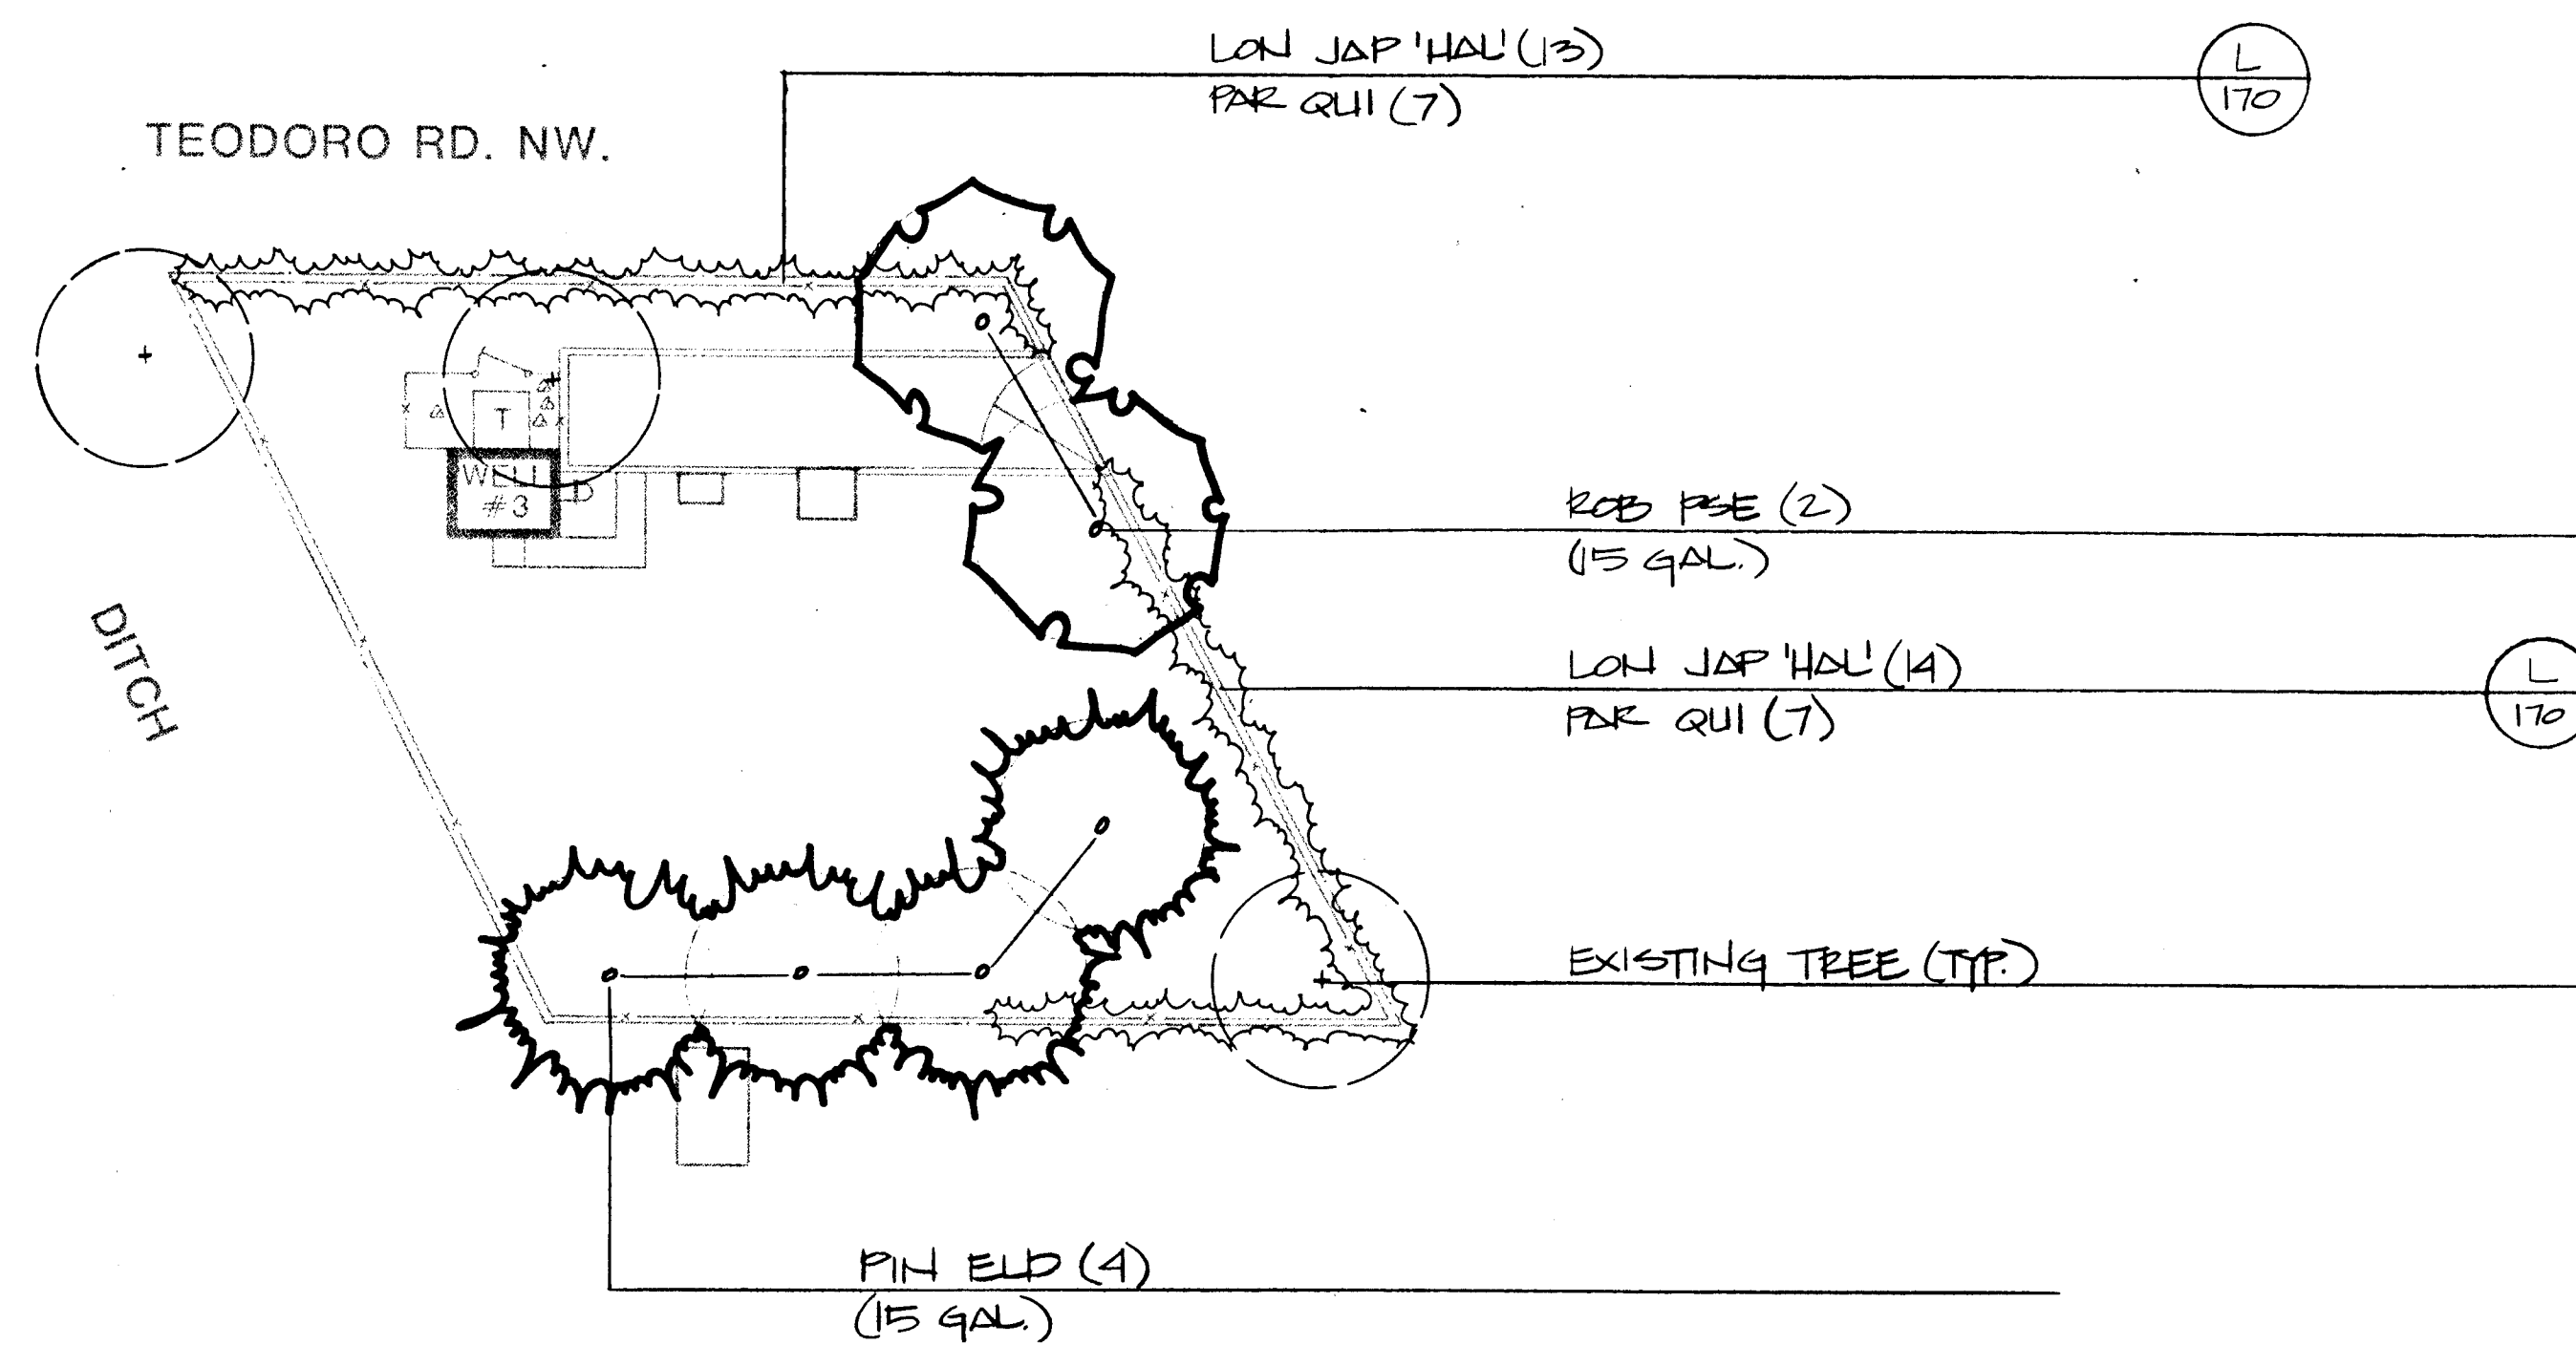


26 3097 3186


SCALE 1"=20'-0"

0 10 20 40

NORTH

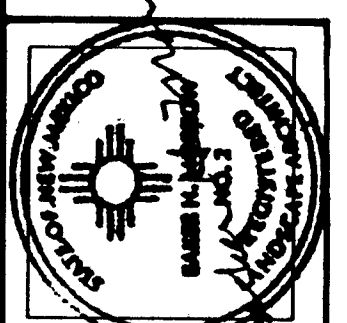

MORROW & COMPANY
LANDSCAPE ARCHITECTS
210 La Veta Drive NE
Albuquerque, New Mexico 87108
505-268-2266

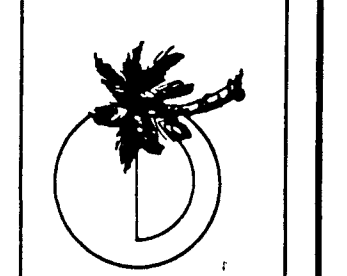



NOVEMBER
1986

AS BUILT

GRIEGOS WELL #3
2322 TEODORO ROAD NW
PLANTING PLAN

LANDSCAPING IMPROVEMENTS FOR
WATER SYSTEM FACILITY SITES
WATER SYSTEMS DIVISION
CITY OF ALBUQUERQUE
ALBUQUERQUE, NEW MEXICO



SHEET
34
172

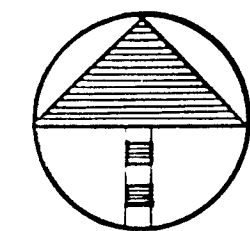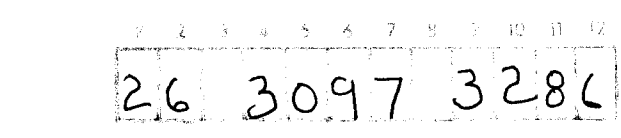


SHEET
35
OF
172

AS BUILT

MORROW & COMPANY
LANDSCAPE ARCHITECTS
210 La Veta Drive NE
Albuquerque, New Mexico 87108
505-268-2266

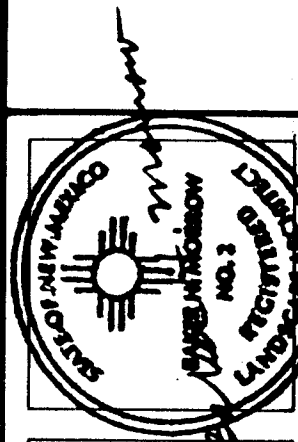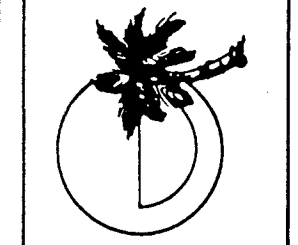


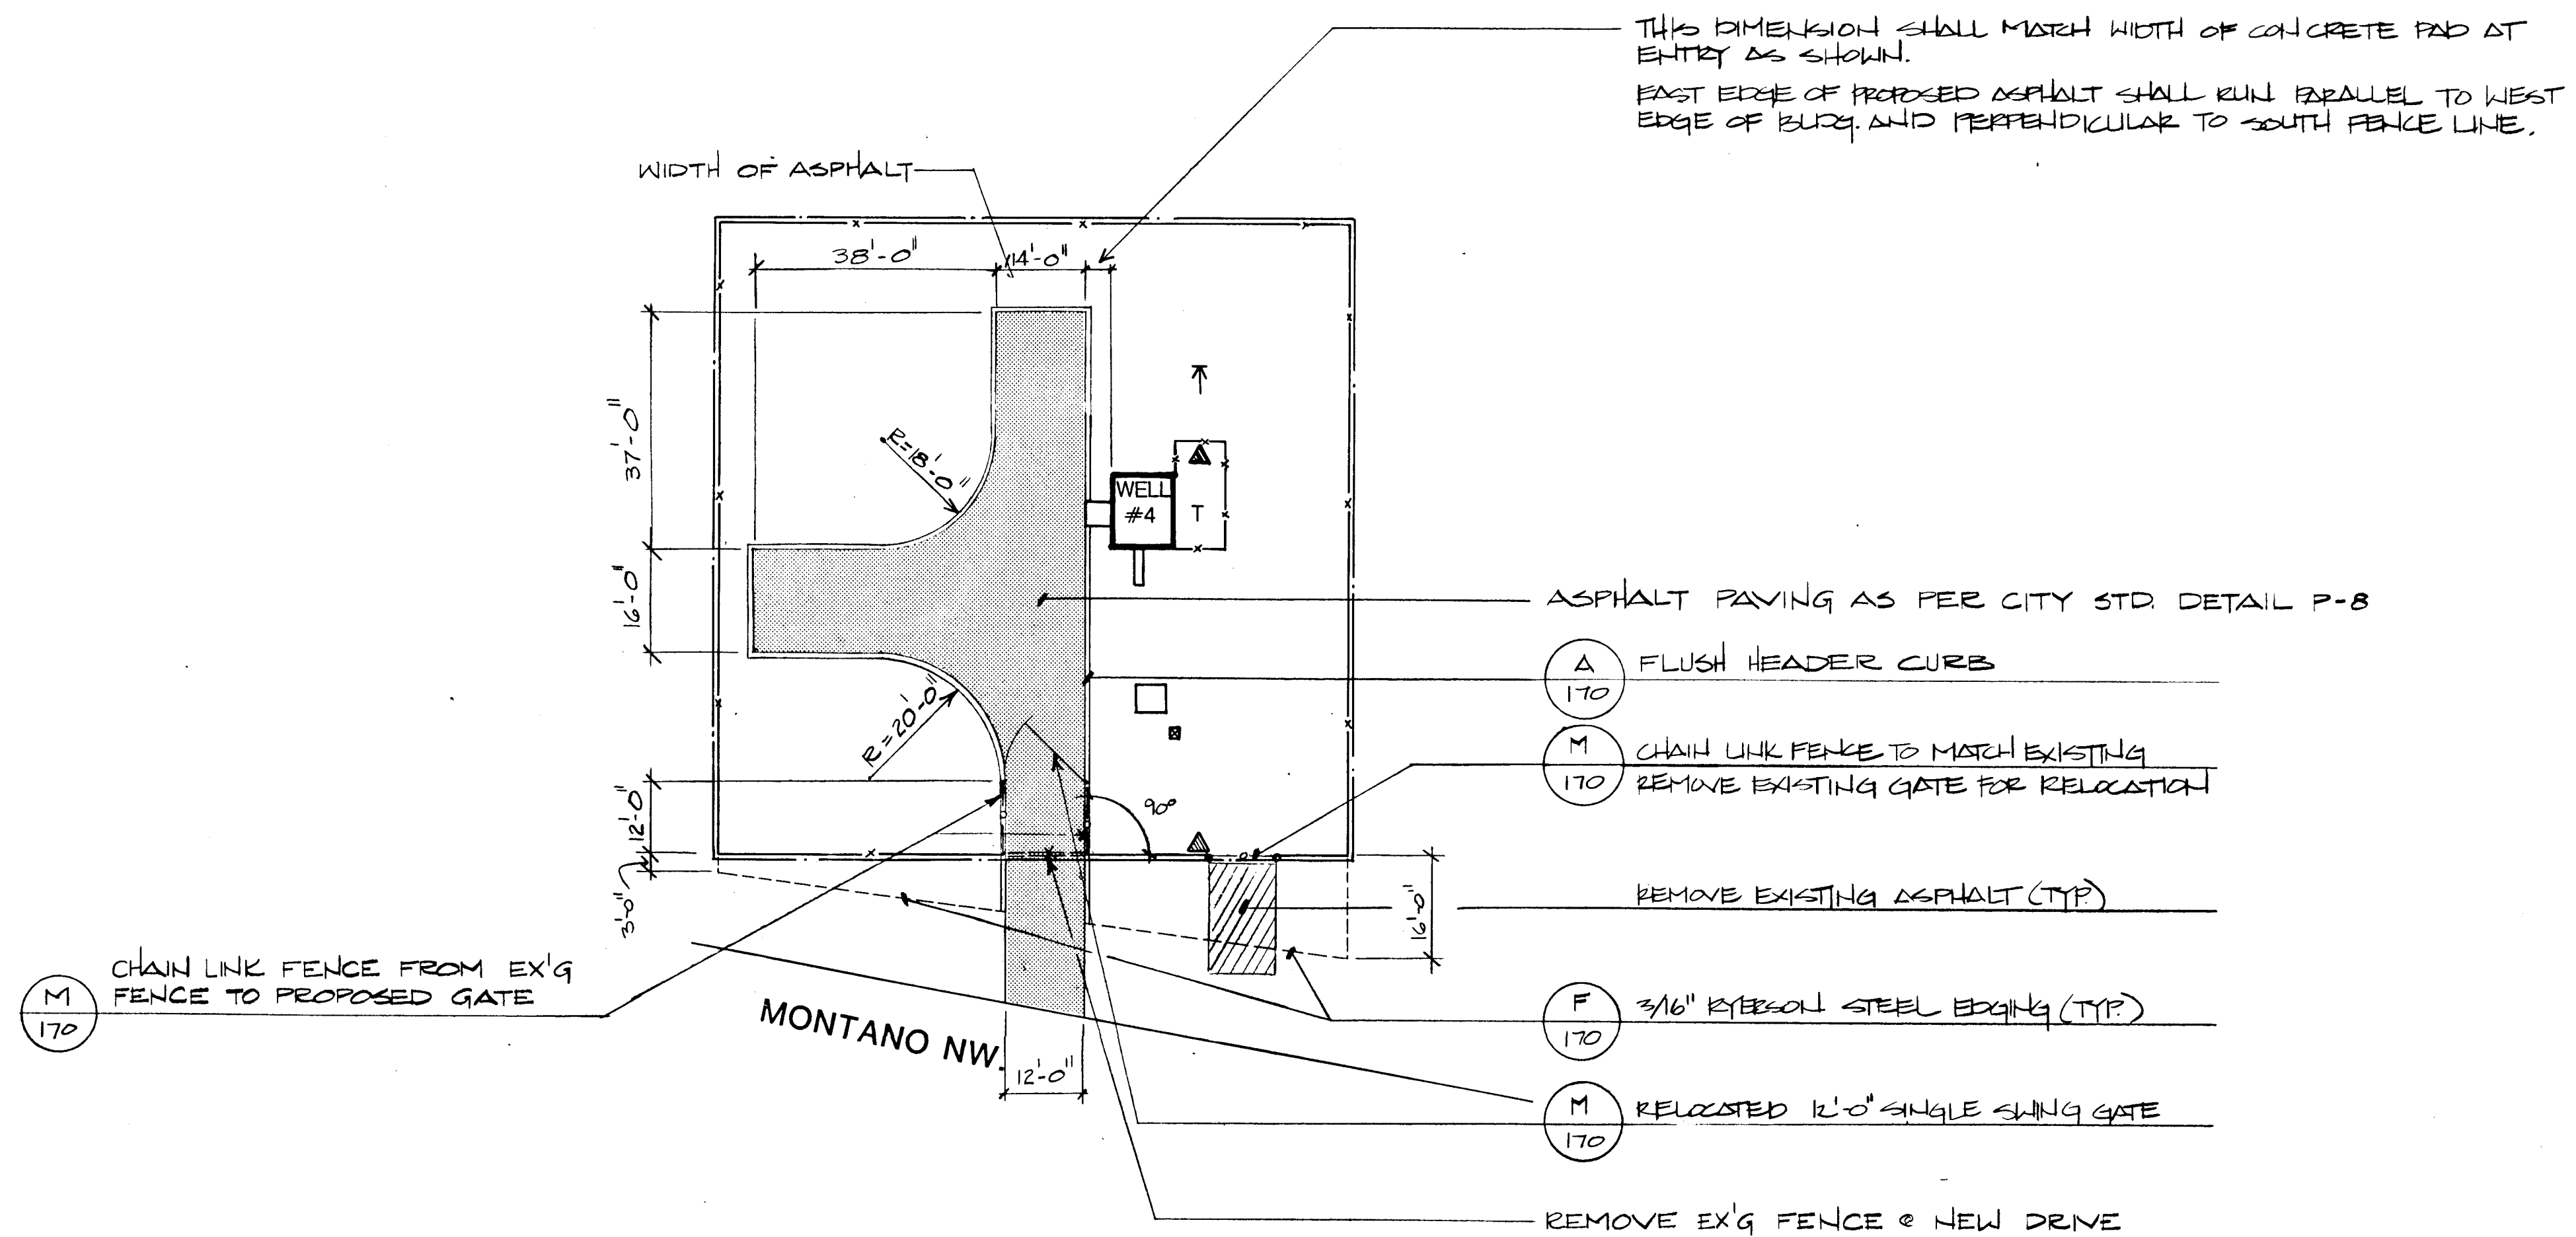

26 30.97 3386

SCALE 1"=20'-0"

0 10 20 40

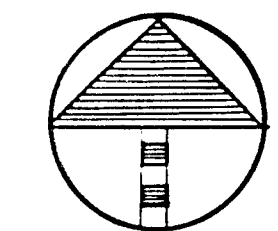

MORROW & COMPANY
LANDSCAPE ARCHITECTS
210 La Veta Drive NE
Albuquerque, New Mexico 87108
505-268-2266





NOVEMBER 1986

AS BUILT

GRIEGOS WELL #4
1105 MONTANO RD NW
CONSTRUCTION PLAN

LANDSCAPING IMPROVEMENTS FOR
WATER SYSTEM FACILITY SITES
WATER SYSTEMS DIVISION
CITY OF ALBUQUERQUE
ALBUQUERQUE, NEW MEXICO

SHEET
3/16
172

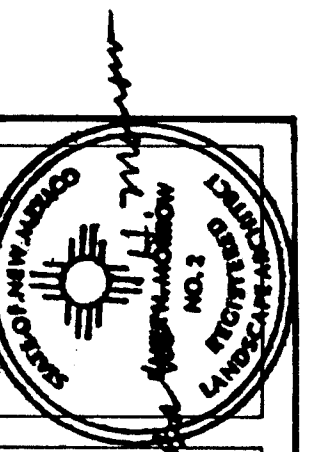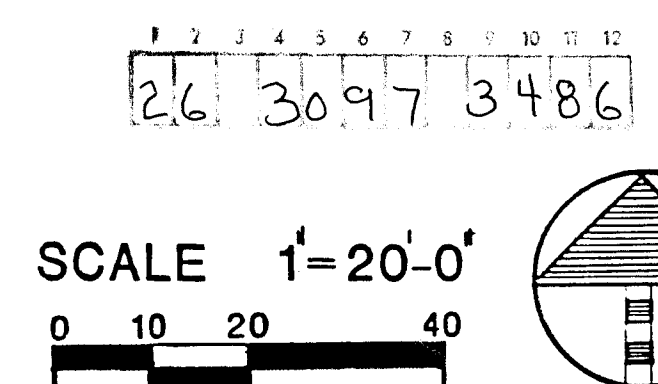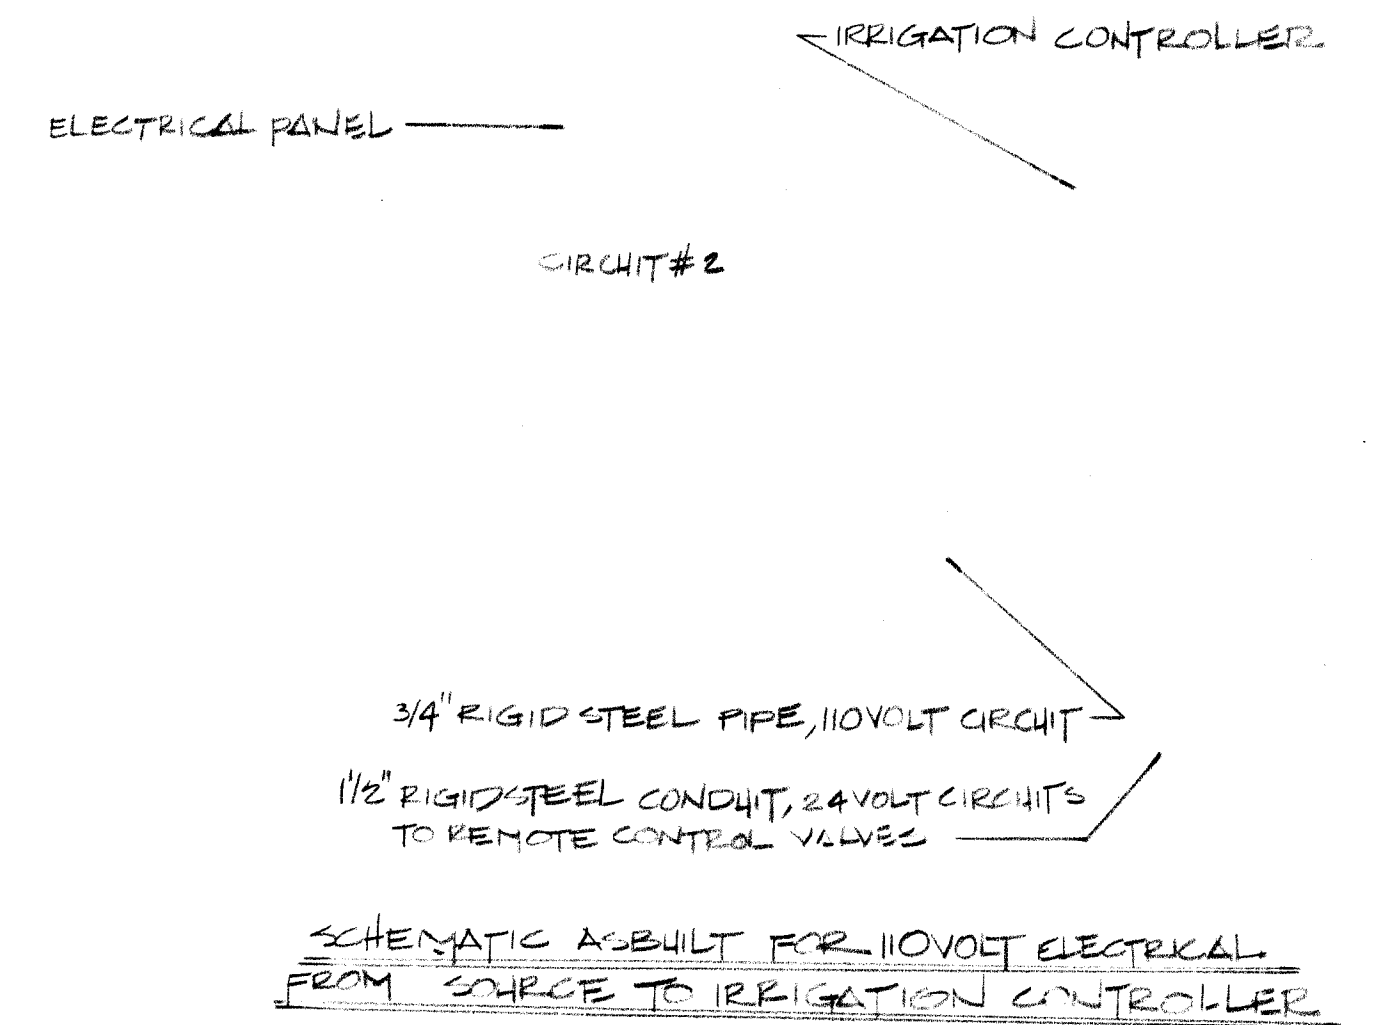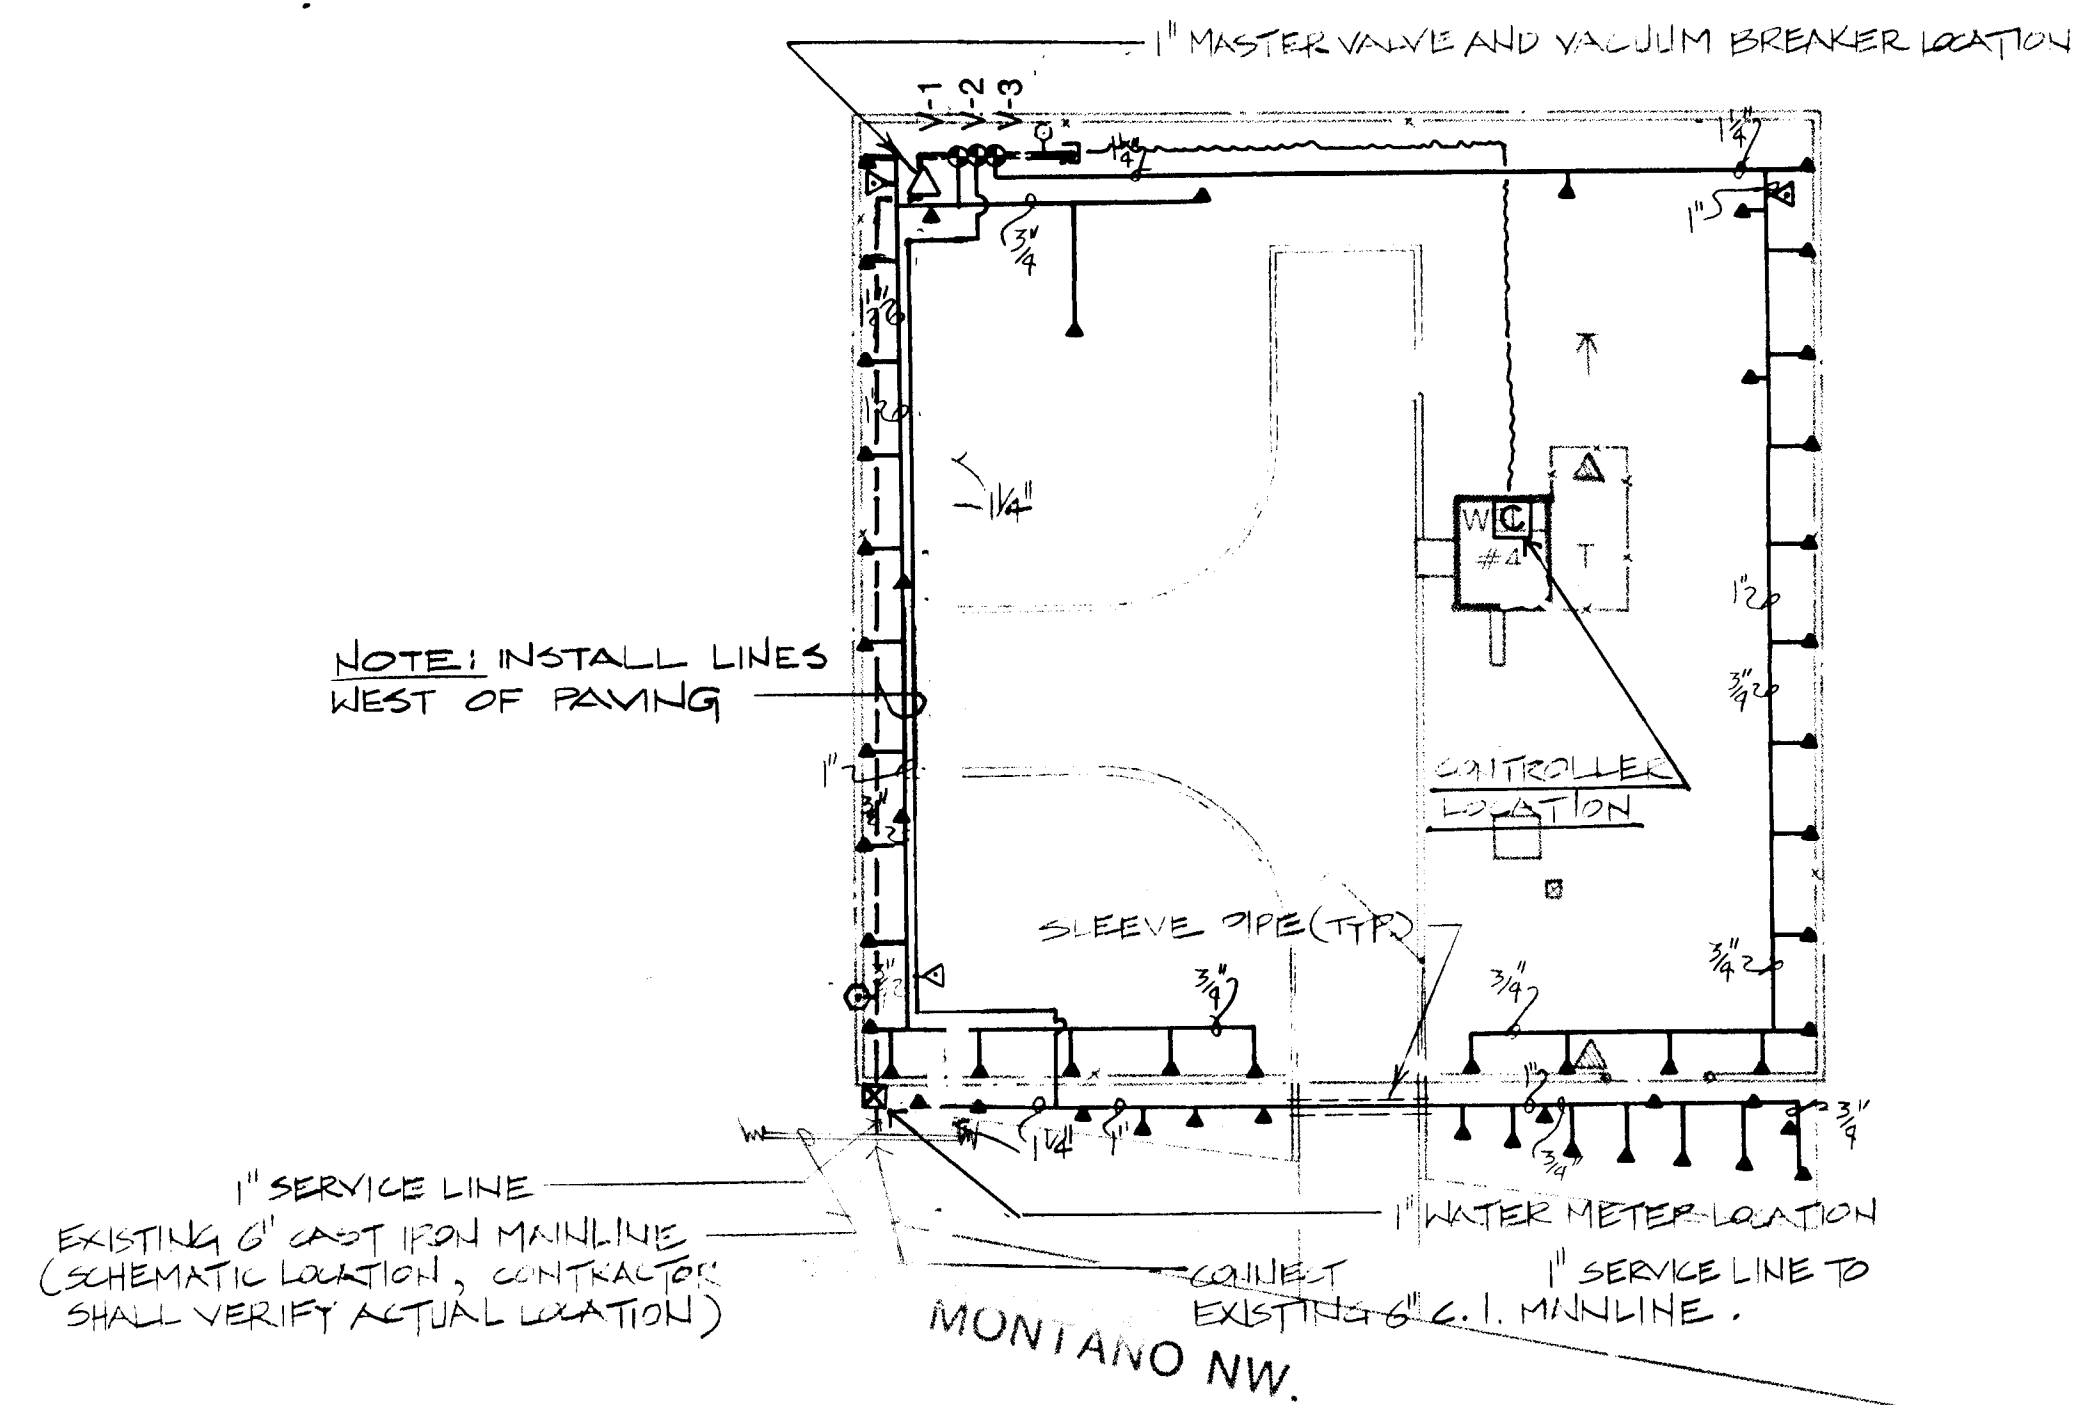

MORROW & COMPANY
LANDSCAPE ARCHITECTS
210 La Veta Drive NE
Albuquerque, New Mexico 87108
505-268-2266




NOVEMBER
1986

AS BUILT

GRIEGOS WELL #4
1105 MONTANO RD NW
IRRIGATION PLAN


LANDSCAPING IMPROVEMENTS FOR
WATER SYSTEM FACILITY SITES
WATER SYSTEMS DIVISION
CITY OF ALBUQUERQUE
ALBUQUERQUE, NEW MEXICO

SHEET
37
021
172

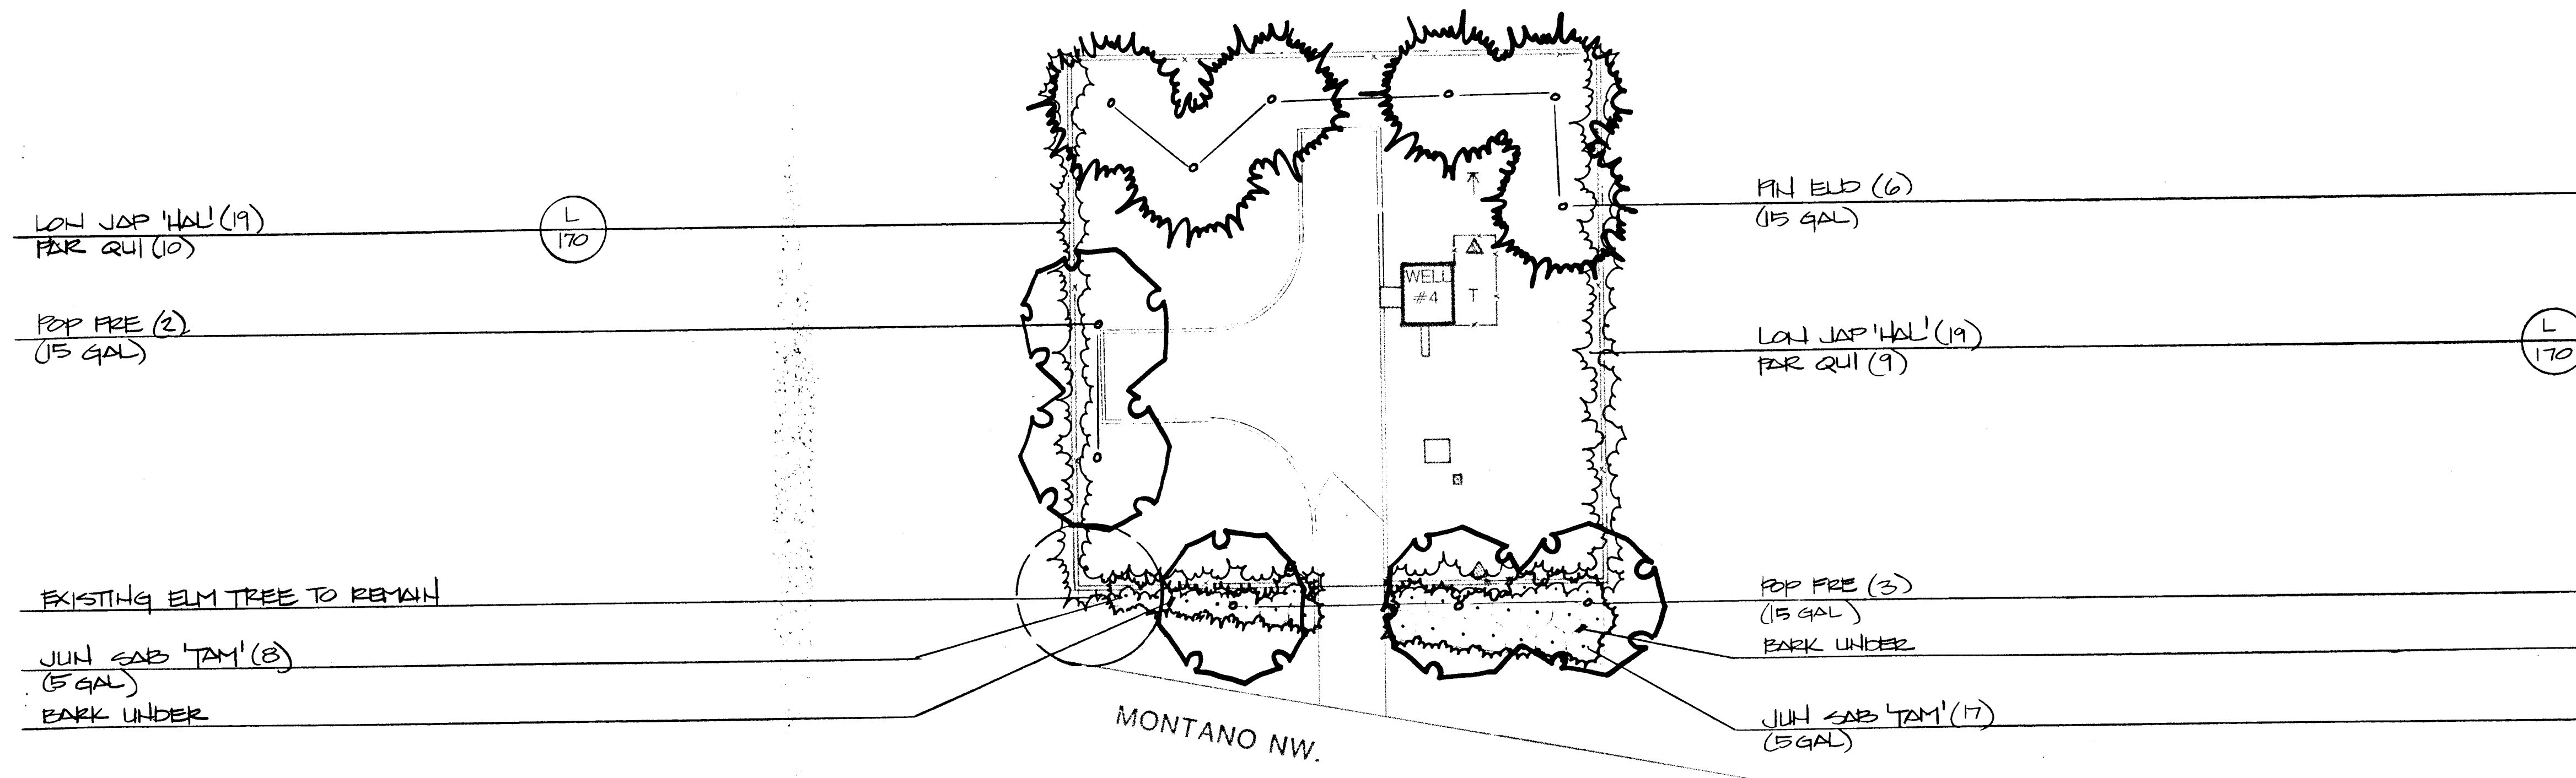

SCALE 1"=20'-0"

0 10 20 40

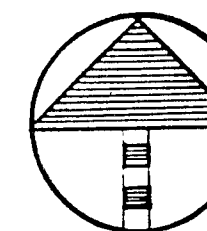

26 3097 3586

SHEET

38

172

LANDSCAPING IMPROVEMENTS FOR

WATER SYSTEM FACILITY SITES

WATER SYSTEMS DIVISION

CITY OF ALBUQUERQUE

ALBUQUERQUE, NEW MEXICO

GRIEGOS WELL #4

1105 MONTANO RD NW

PLANTING PLAN

AS BUILT

NOVEMBER

1986




MORROW & COMPANY



LANDSCAPE ARCHITECTS

210 La Veta Drive NE

Albuquerque, New Mexico 87108


505-268-2266

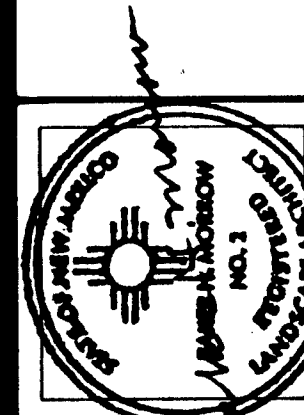


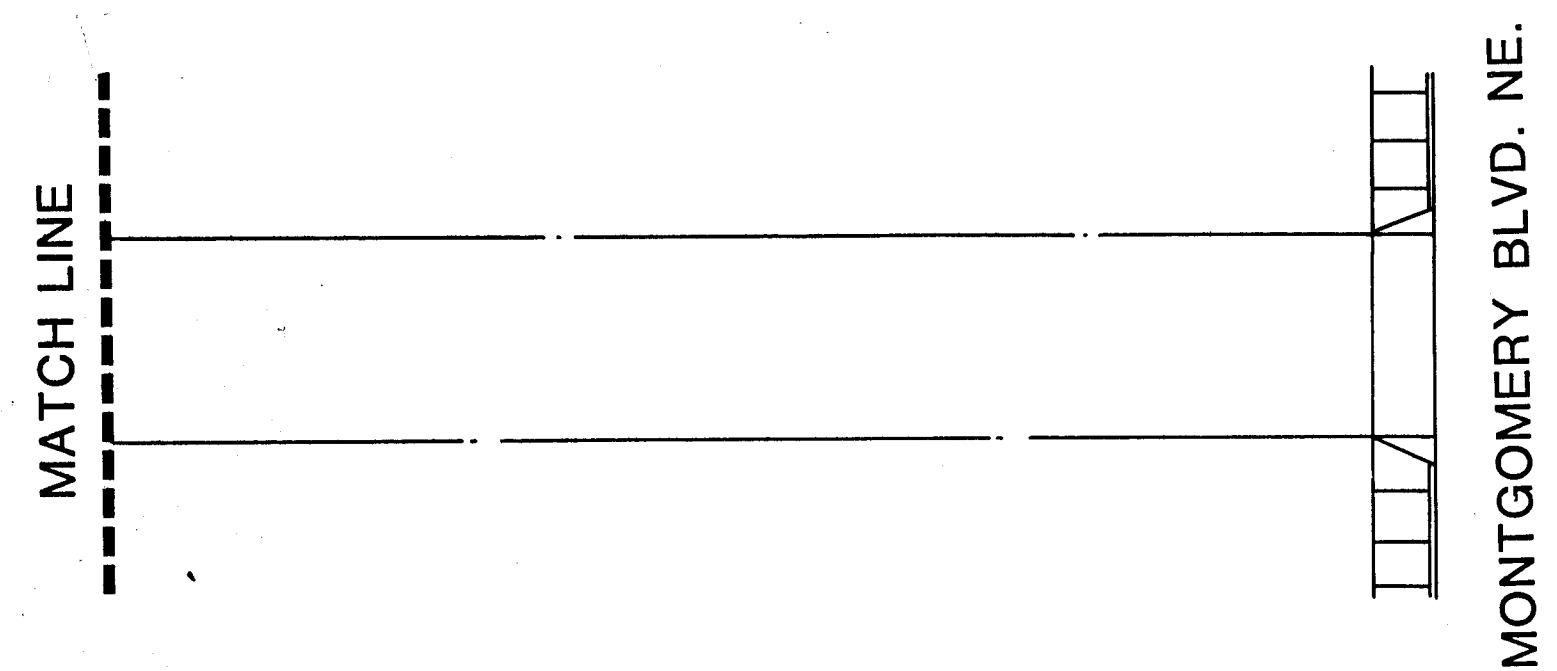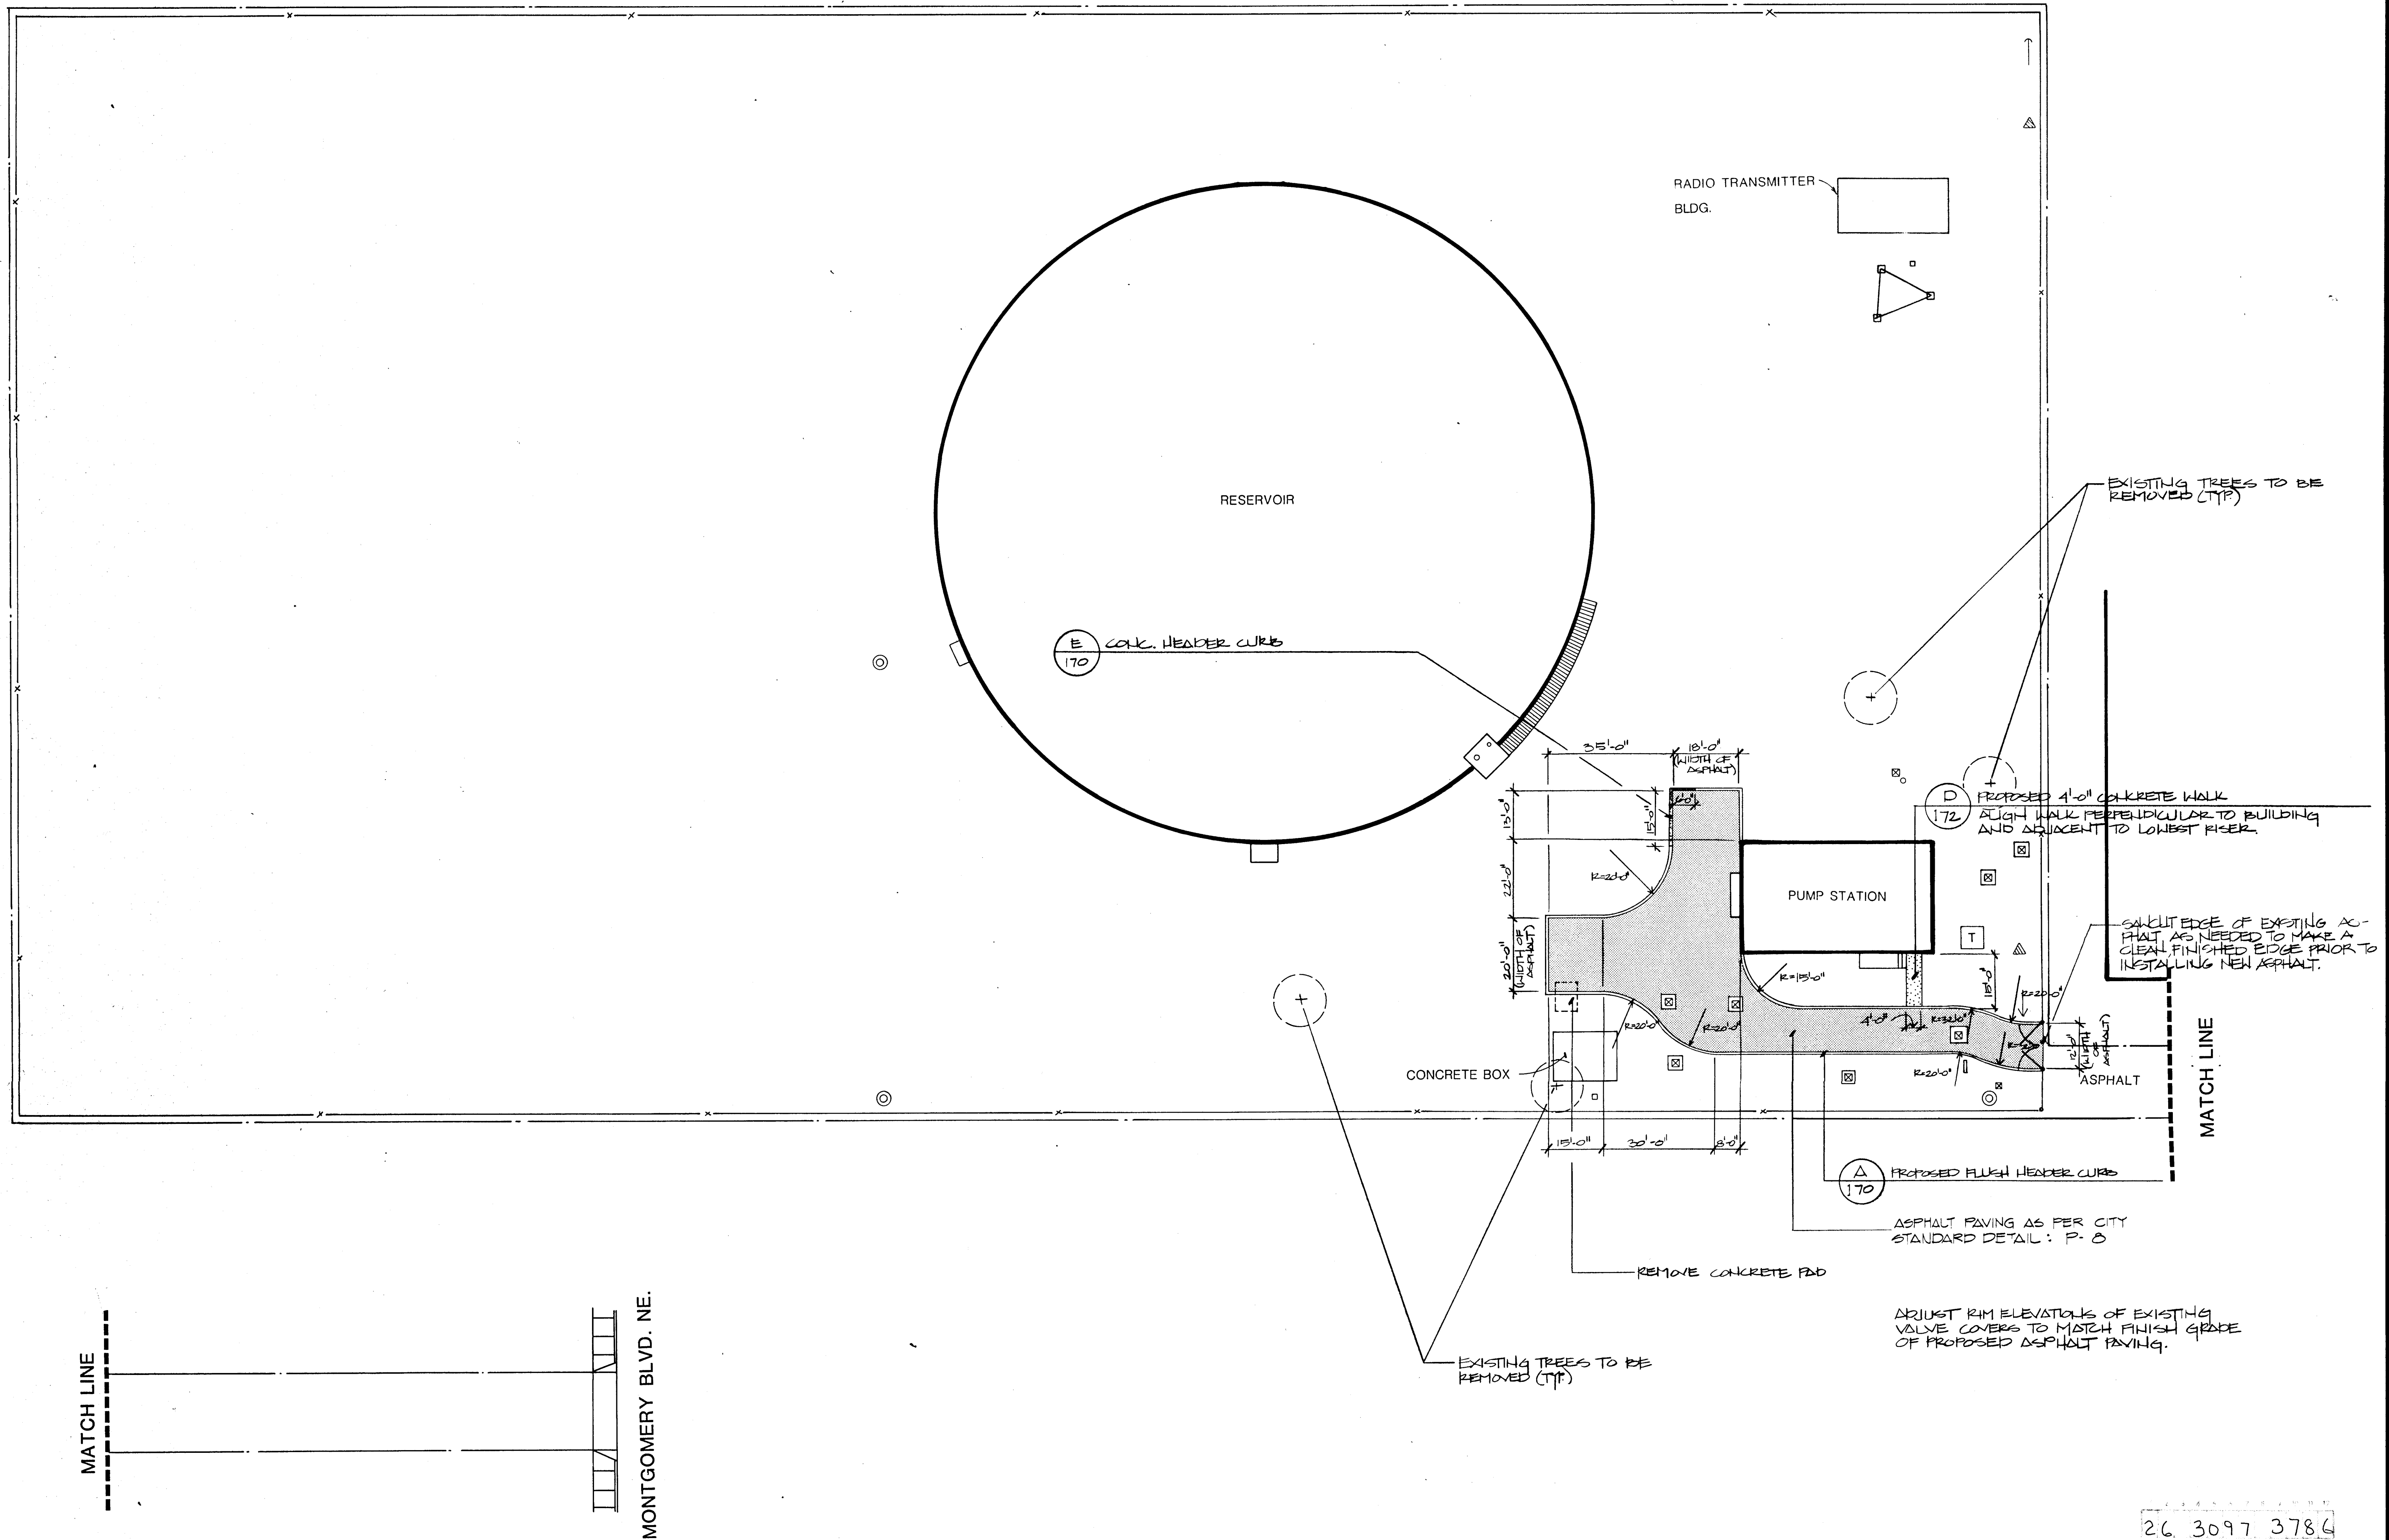

26 3097 3786

SCALE 1"=20'-0"
0 10 20 40

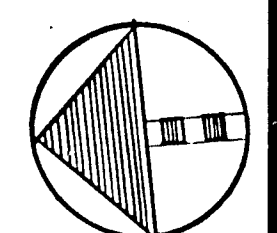

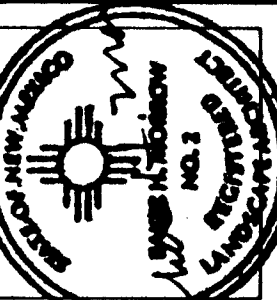

MORROW & COMPANY
LANDSCAPE ARCHITECTS
210 La Veta Drive NE
Albuquerque, New Mexico 87108
505-268-2266



NOVEMBER 1986

GUTIERREZ RESERVOIR & PUMP STATION
11523 MONTGOMERY BLVD.
CONSTRUCTION PLAN


AS BUILT

LANDSCAPING IMPROVEMENTS FOR
WATER SYSTEM FACILITY SITES
WATER SYSTEMS DIVISION
CITY OF ALBUQUERQUE
ALBUQUERQUE, NEW MEXICO

SHEET
40
172

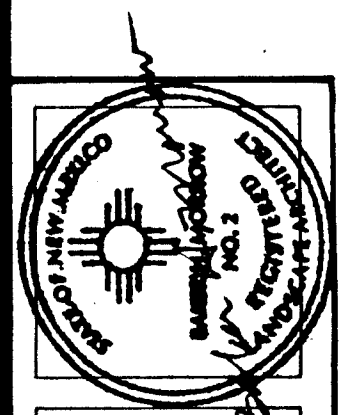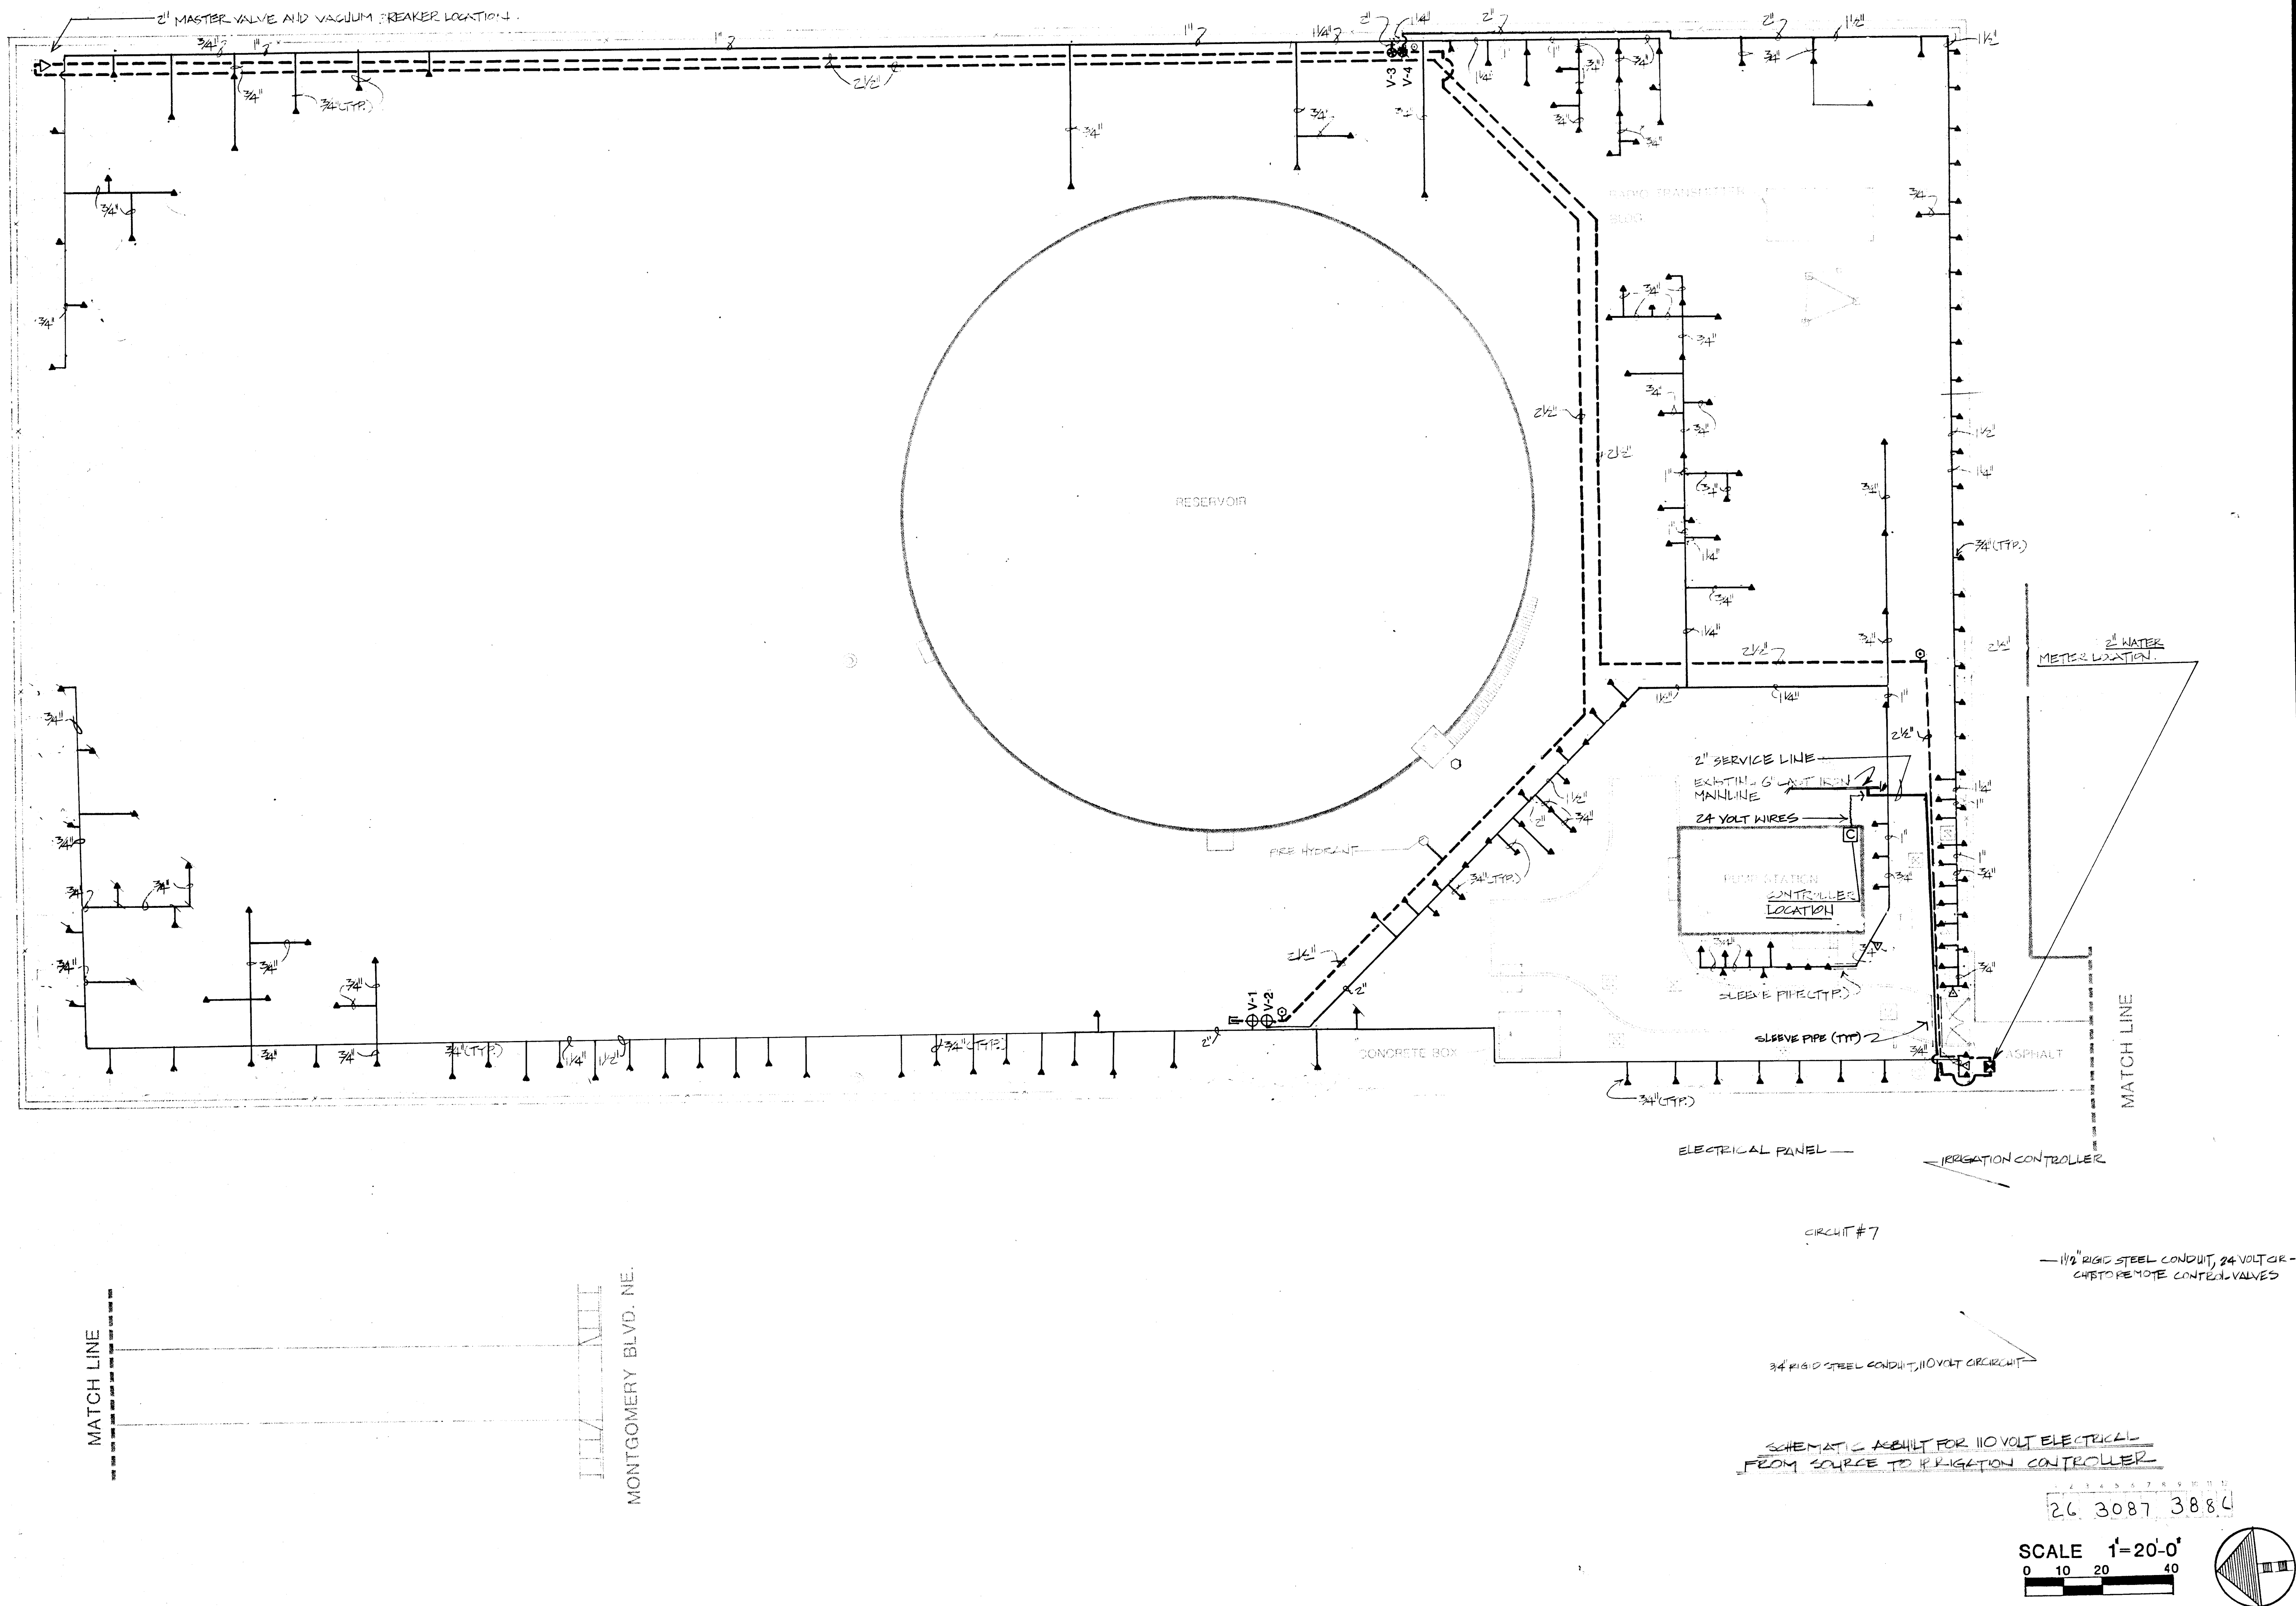

MORROW & COMPANY
 LANDSCAPE ARCHITECTS
 210 La Veta Drive NE
 Albuquerque, New Mexico 87108
 505-268-2266

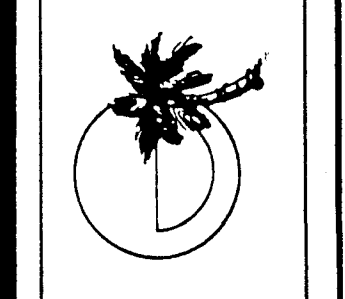

NOVEMBER
 1986


**GUTIERREZ RESERVOIR & PUMP STATION
 11523 MONTGOMERY BLVD.
 IRRIGATION PLAN**



LANDSCAPING IMPROVEMENTS FOR
WATER SYSTEM FACILITY SITES
 WATER SYSTEMS DIVISION
 CITY OF ALBUQUERQUE
 ALBUQUERQUE, NEW MEXICO

SHEET
 41
 OF
 172


26.3087 3884

SCALE 1"=20'-0"
 0 10 20 40

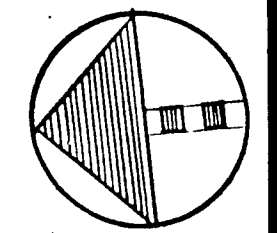

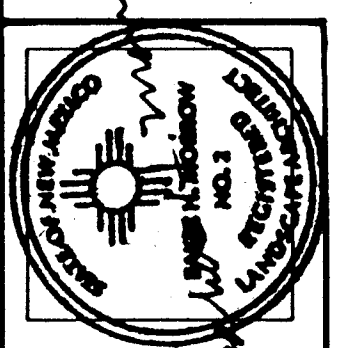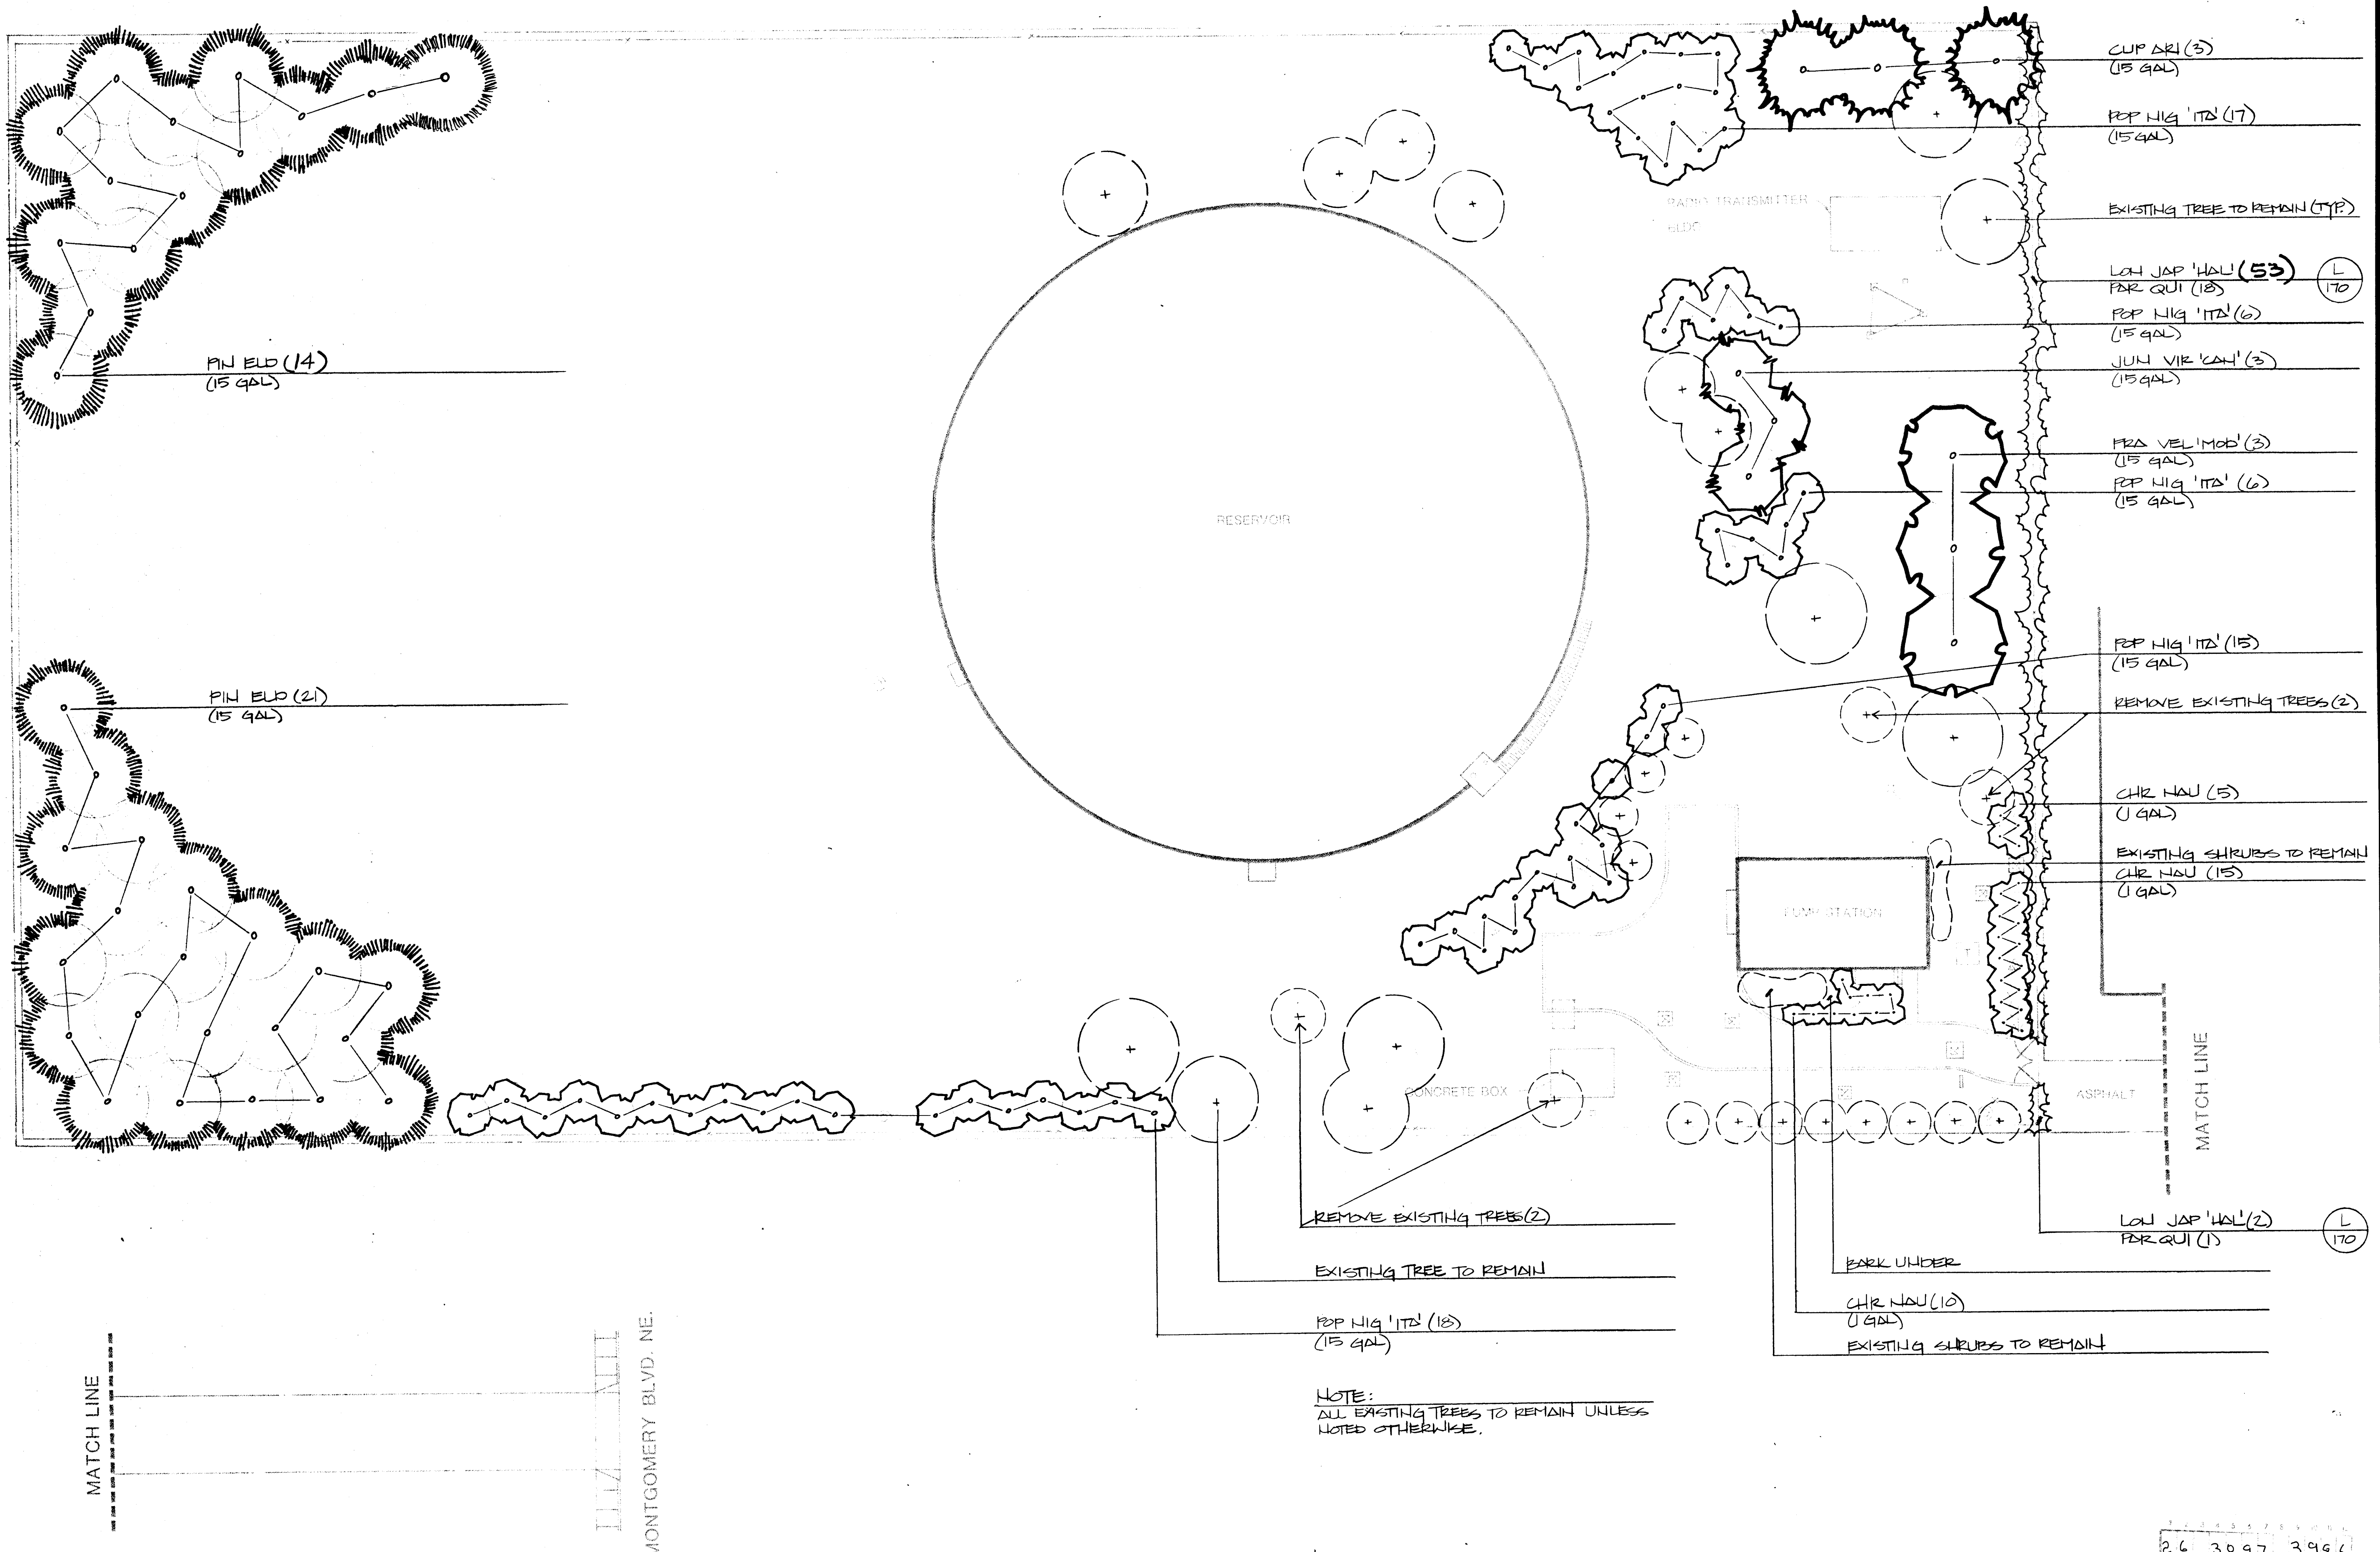

MORROW & COMPANY
LANDSCAPE ARCHITECTS
210 La Veta Drive NE
Albuquerque, New Mexico 87108
505-268-2266

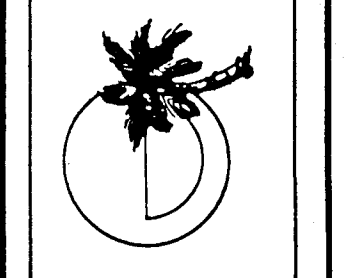



NOVEMBER
1986

AS BUILT
GUTIERREZ RESERVOIR & PUMP STATION
11523 MONTGOMERY BLVD.
PLANTING PLAN

LANDSCAPING IMPROVEMENTS FOR
WATER SYSTEM FACILITY SITES
WATER SYSTEMS DIVISION
CITY OF ALBUQUERQUE
ALBUQUERQUE, NEW MEXICO

SHEET
42
172

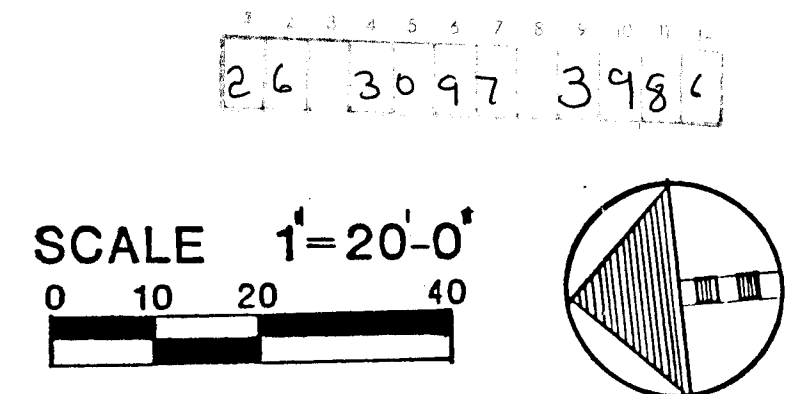

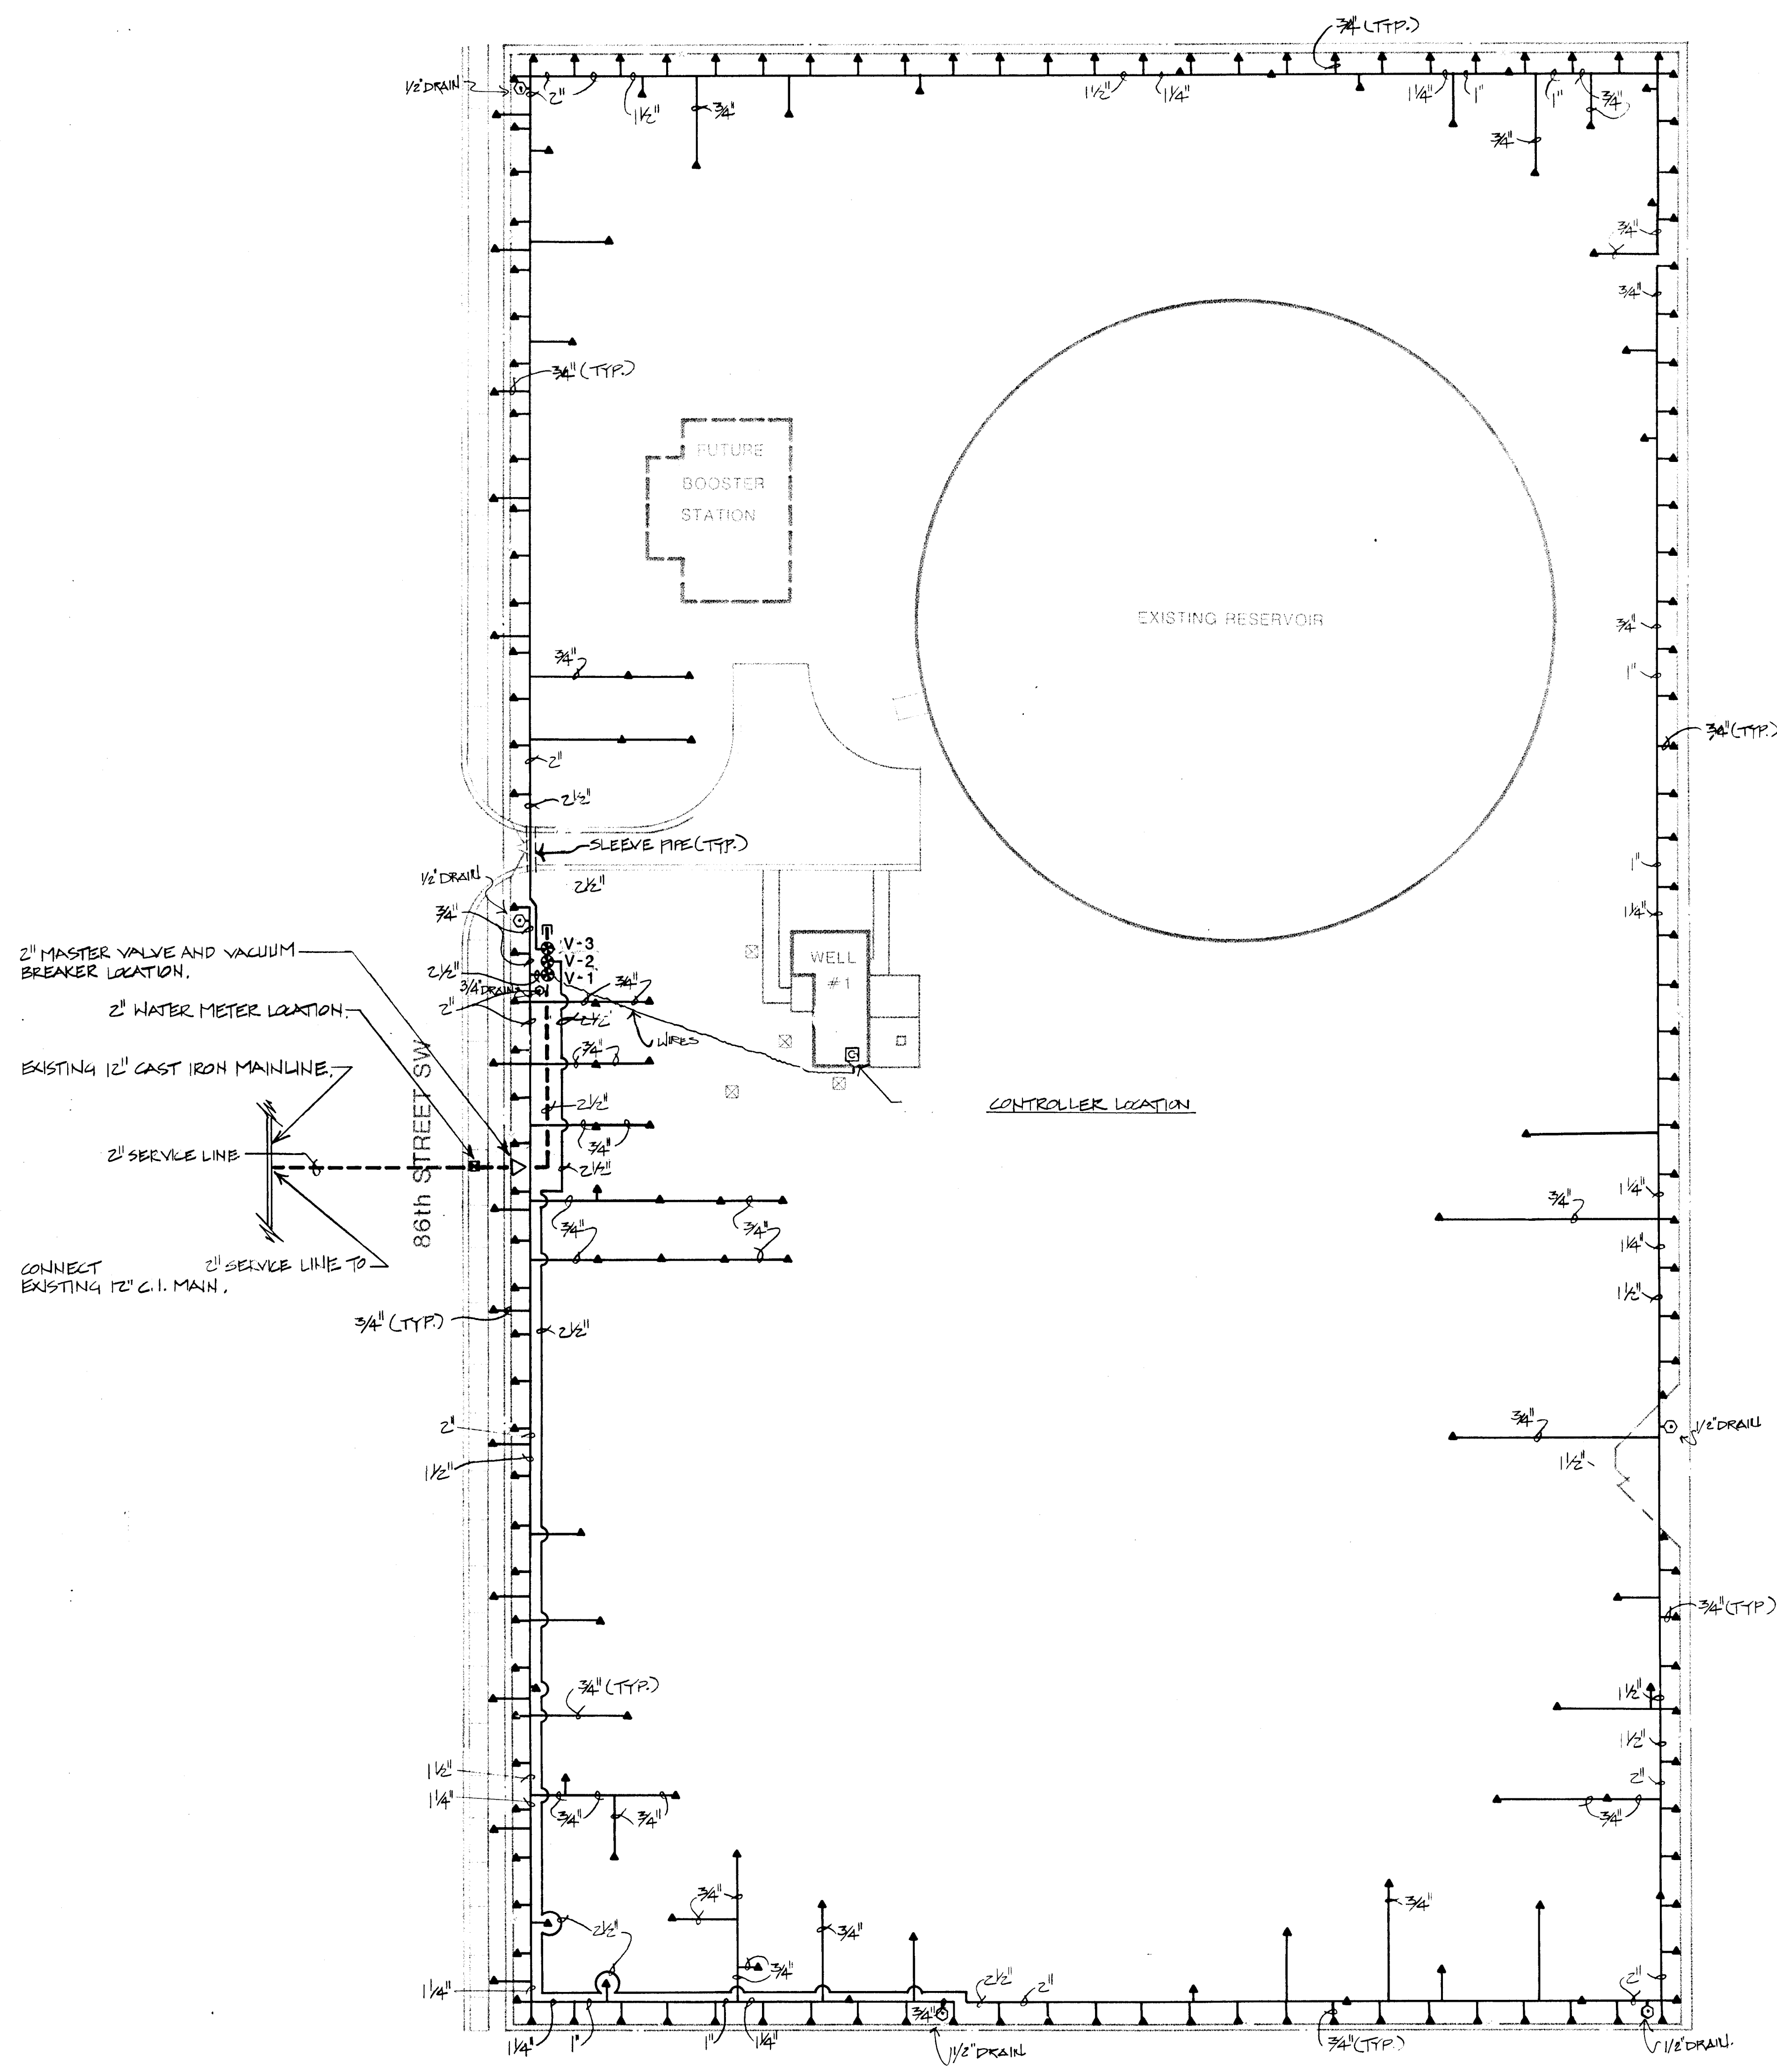

2" MASTER VALVE AND VACUUM BREAKER LOCATION.
 2" WATER METER LOCATION.
 EXISTING 12" CAST IRON MAINLINE.
 2" SERVICE LINE
 86th STREET SW
 2" SERVICE LINE TO
 CONNECT EXISTING 12" C.I. MAIN.

ELECTRICAL PANEL →
 → IRRIGATION CONTROLLER
 CIRCUIT # 2
 3/4" RIGID STEEL CONDUIT, 110VOLT CIRCUIT
 1/2" RIGID STEEL CONDUIT, 24VOLT CIRCUITS
 TO REMOTE CONTROL VALVES
SCHEMATIC AS BUILT FOR 110VOLT ELECTRICAL
FROM SOURCE TO IRRIGATION CONTROLLER

26 3-097 4084

SCALE 1"=20'-0"
 0 10 20 40

MORROW & COMPANY
 LANDSCAPE ARCHITECTS
 210 La Veta Drive NE
 Albuquerque, New Mexico 87108
 505-268-2266

NOVEMBER
1986

AS BUILT

LEAVITT WELL #1 & RESERVOIR
 1320 86th STREET SW
 IRRIGATION PLAN

LANDSCAPING IMPROVEMENTS FOR
WATER SYSTEM FACILITY SITES
 WATER SYSTEMS DIVISION
 CITY OF ALBUQUERQUE
 ALBUQUERQUE, NEW MEXICO

SHEET
 48
 172

RYERSON STEEL EDGE (F 170)

BARK MULCH BETWEEN
SIDEWALK & FENCE

LOH JAP 'HAL' (137) (L 170)
PAR QUI (47)

PLA ACE (5)
(15 GALLON)

MAL SYL (4)
(15 GAL)

MAL SYL (14)
(15 GAL)


PLA ACE (8)
(15 GALLON)

LOH JAP 'HAL' (110) (L 170)
PAR QUI (47)


BARK MULCH BETWEEN
SIDEWALK & FENCE

NOTE:
INSTALL VINES BETWEEN SIDEWALK
AND FENCE AT NORTH END OF SITE

RYERSON STEEL EDGE (F 170)

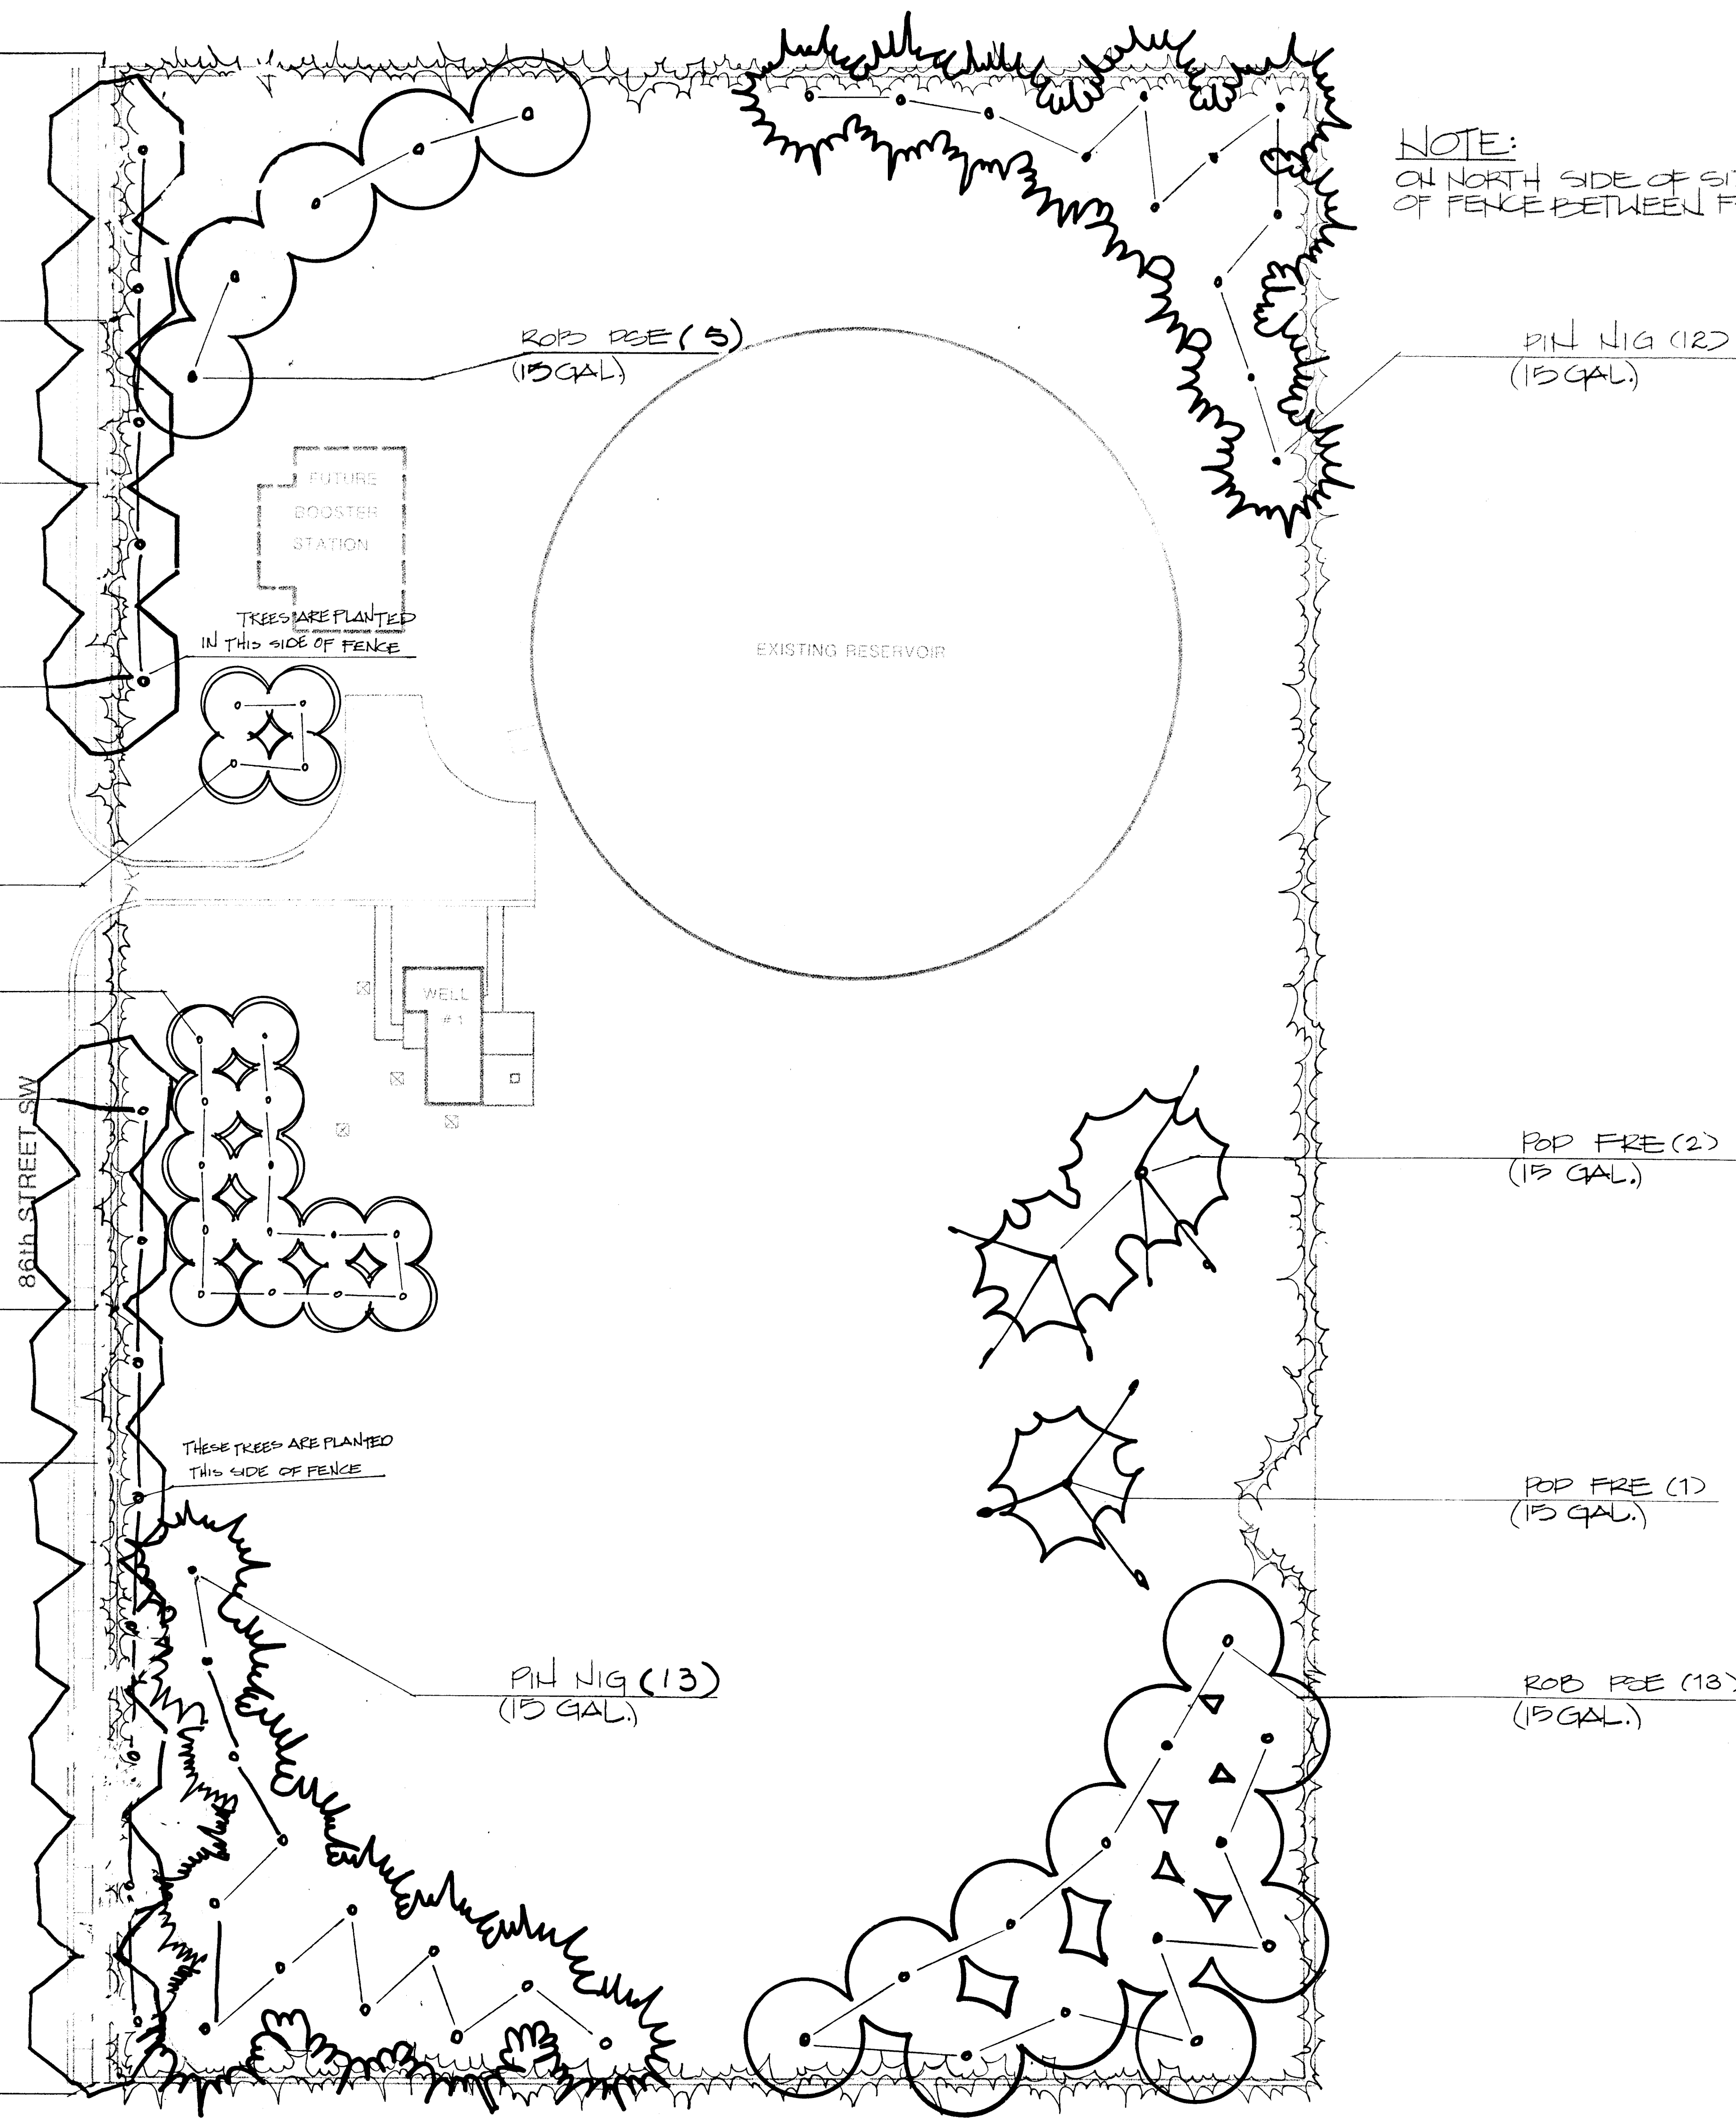

NOTE:
ON NORTH SIDE OF SITE PLANT VINES IN FRONT
OF FENCE BETWEEN FENCE AND SIDEWALK.

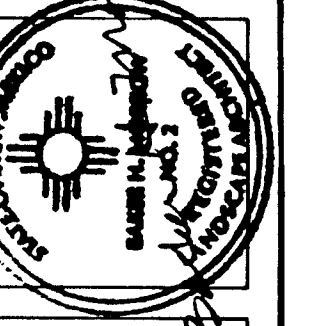

MORROW & COMPANY
LANDSCAPE ARCHITECTS
210 La Veta Drive NE
Albuquerque, New Mexico 87108
505-268-2266



NOVEMBER
1986


LEAVITT WELL #1 & RESERVOIR
1320 86th STREET SW
AS BUILT
PLANTING PLAN

LANDSCAPING IMPROVEMENTS FOR
WATER SYSTEM FACILITY SITES
WATER SYSTEMS DIVISION
CITY OF ALBUQUERQUE
ALBUQUERQUE, NEW MEXICO


SHEET
49
97
172

26 3097 4186

SCALE 1"=20'-0"
0 10 20 40

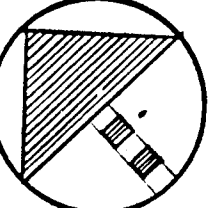

CAMINO SAN MARTIN SW

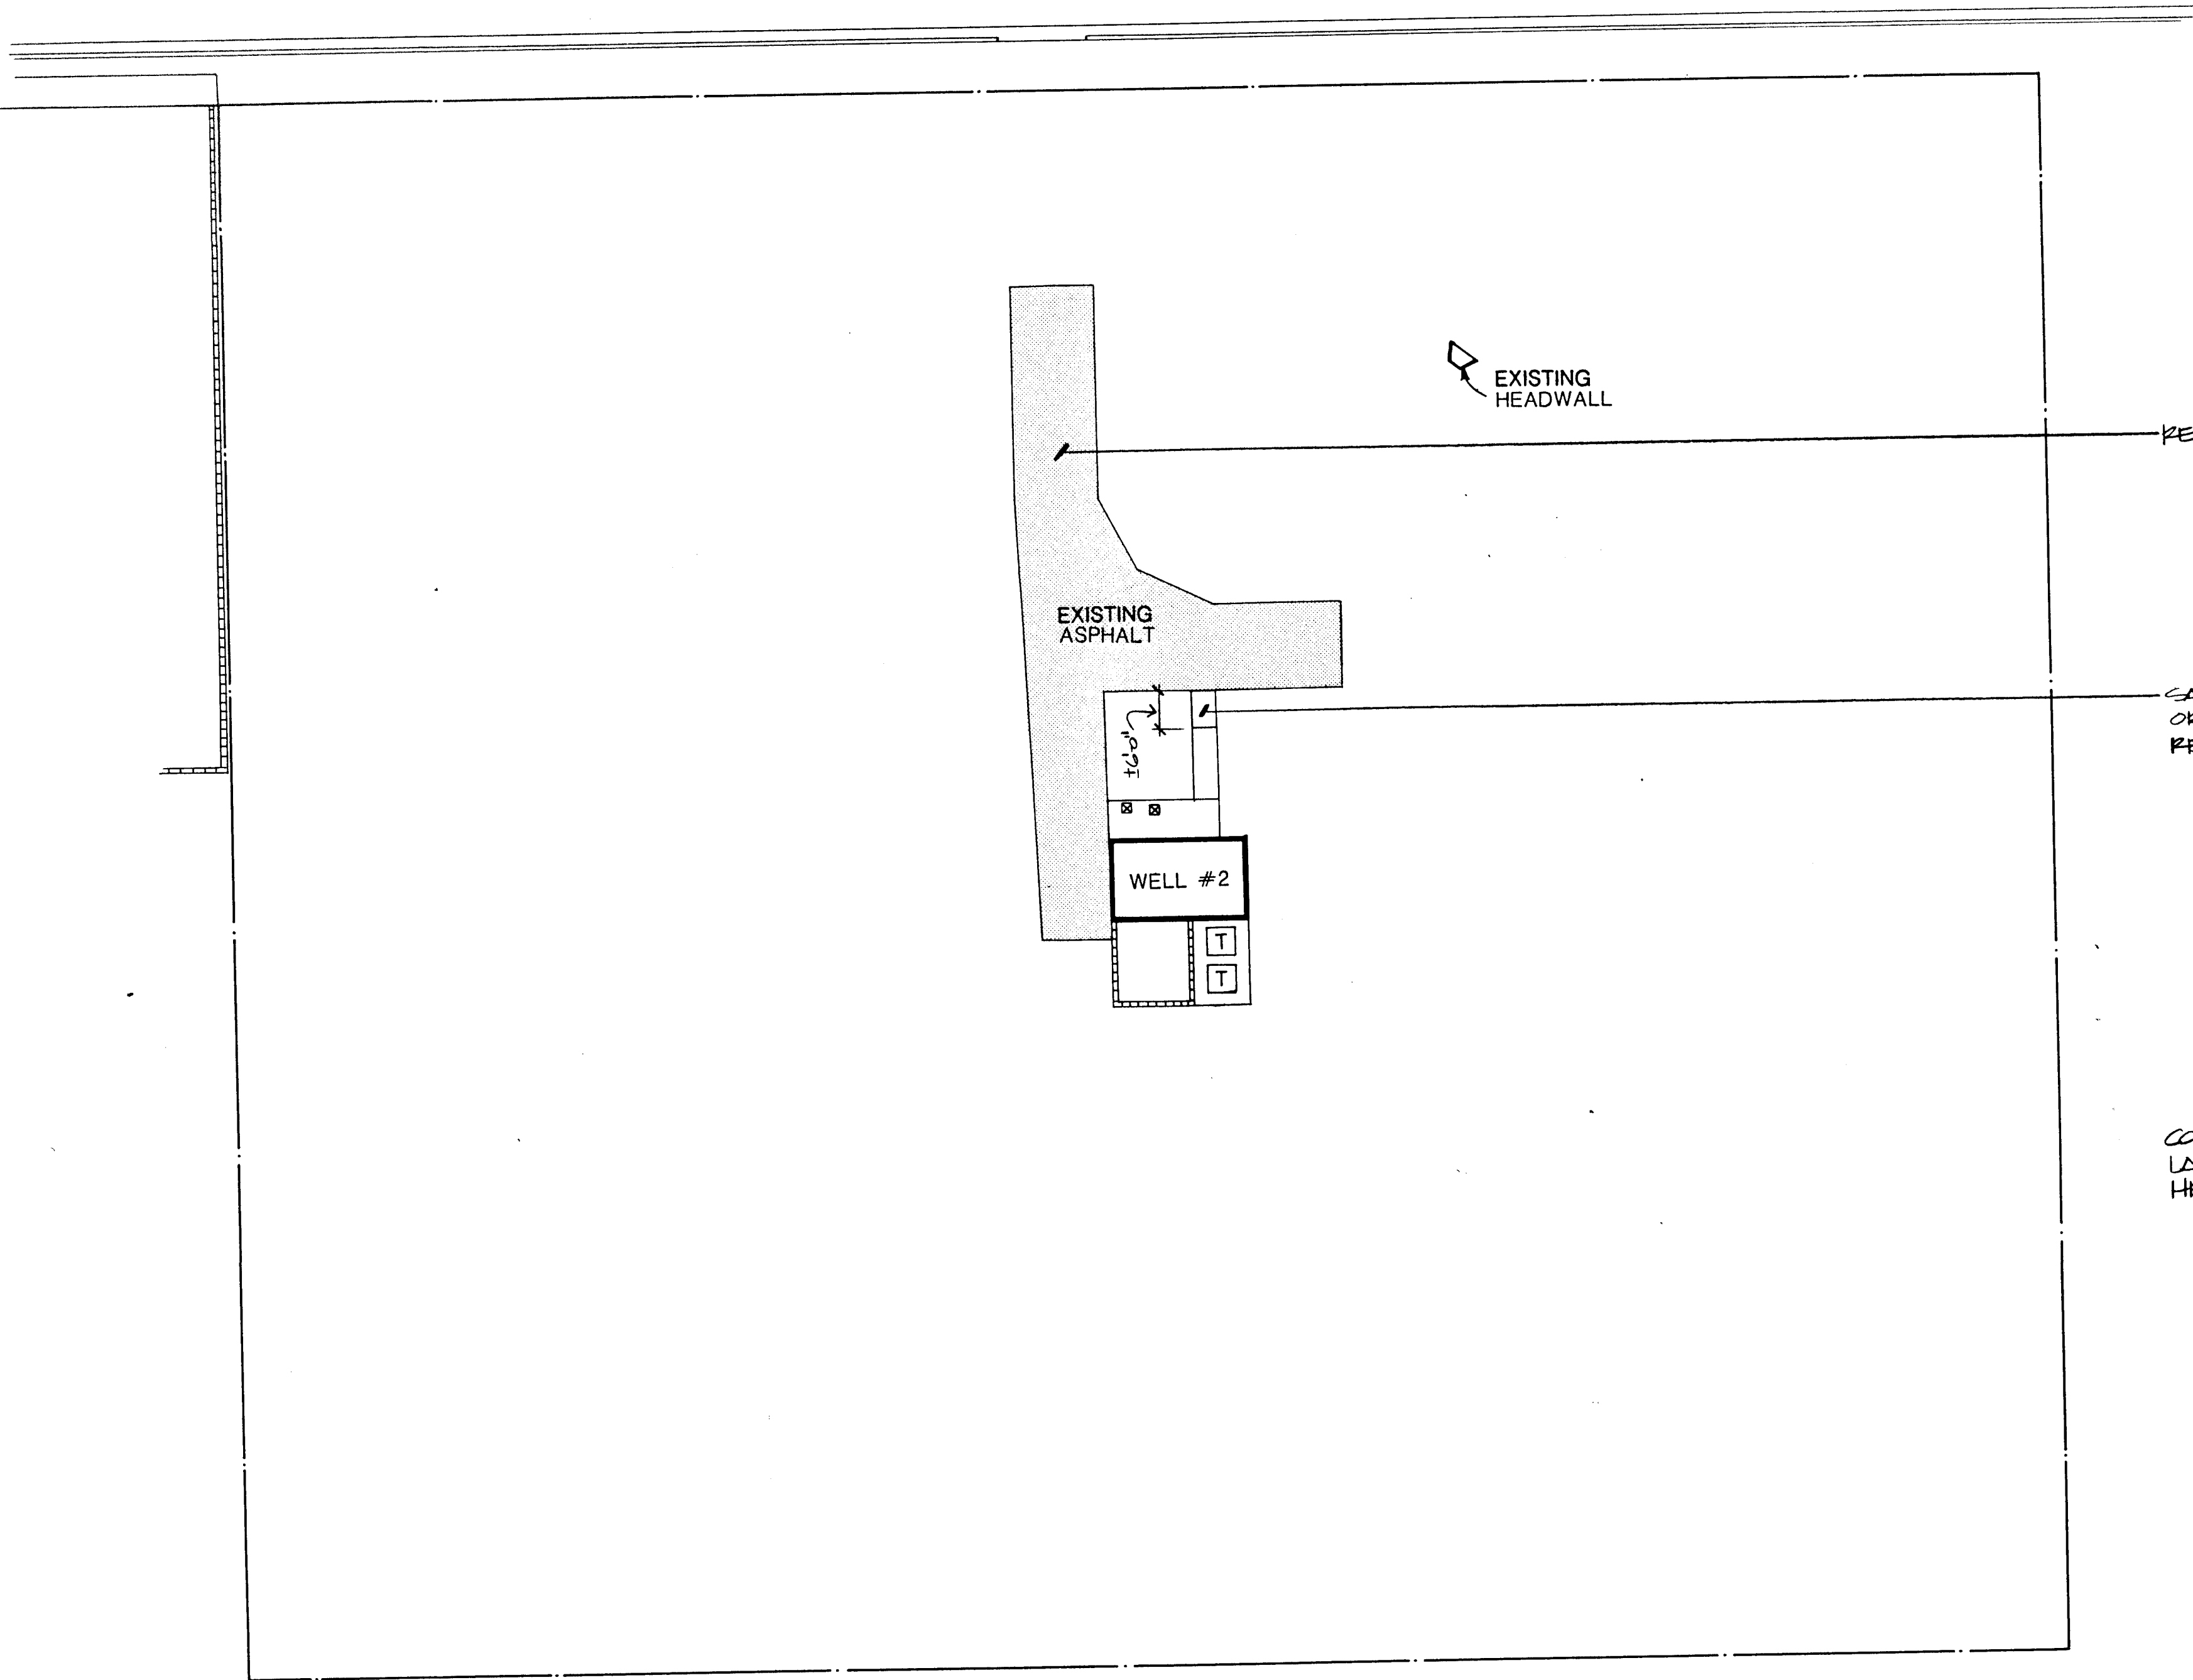



REMOVE ALL EXISTING ASPHALT

SAW-CUT CONCRETE WALK AT FIRST CONTROL JOINT OR EXPANSION JOINT FROM NORTH END OF WALK AND REMOVE CONCRETE


CONTRACTOR SHALL REMOVE ALL MISC. SURFACE DEBRIS. LARGE ROCKS AND SECTIONS OF CONCRETE BELOW EXISTING HEADWALL SHALL REMAIN.

26 3097 4286

SCALE 1" 20'-0"
0 10 20 40

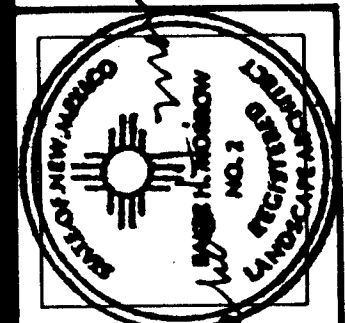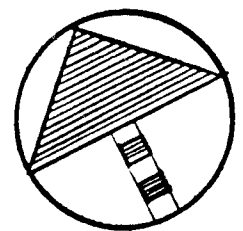

MORROW & COMPANY
LANDSCAPE ARCHITECTS
210 La Veta Drive NE
Albuquerque, New Mexico 87108
505-268-2266

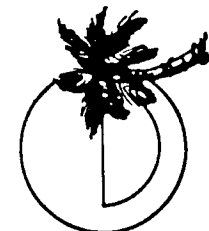


NOVEMBER
1986

AS BUILT

LEAVITT WELL #2
8404 CAMINO SAN MARTIN SW
DEMOLITION PLAN



LANDSCAPING IMPROVEMENTS FOR
WATER SYSTEM FACILITY SITES
WATER SYSTEMS DIVISION
CITY OF ALBUQUERQUE
ALBUQUERQUE, NEW MEXICO

SHEET
1-2

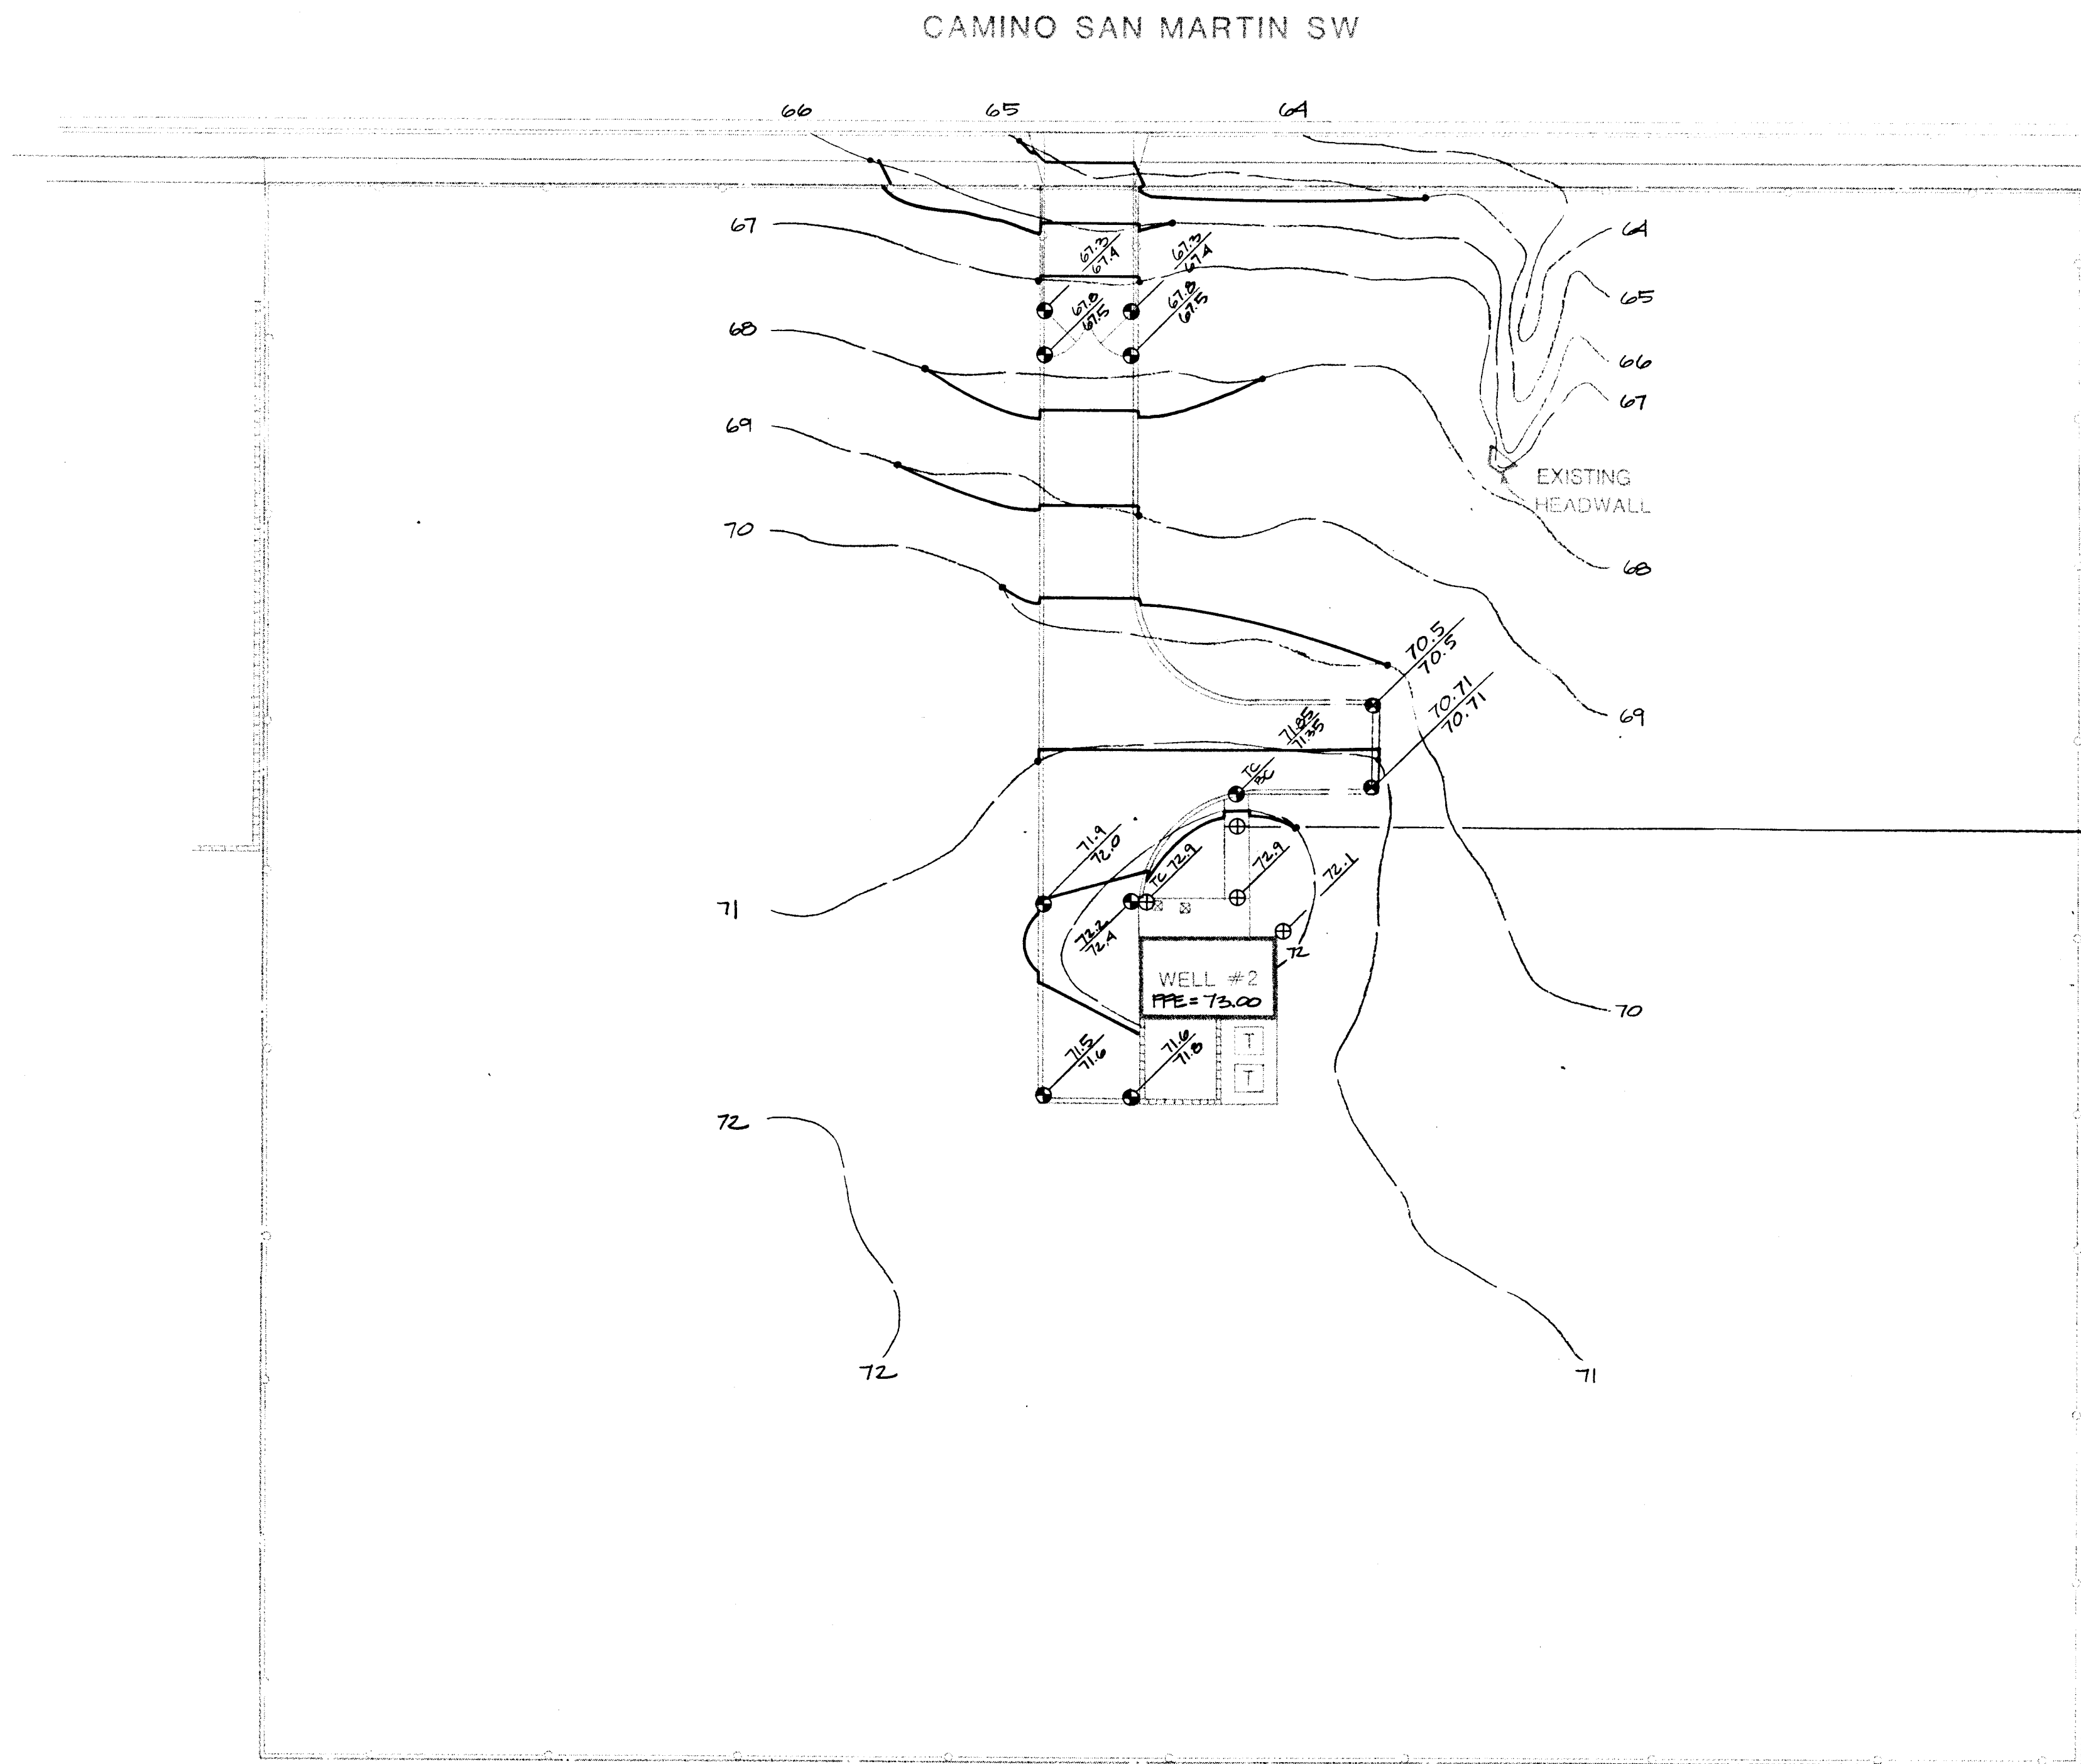

26 3097 4386

SCALE 1" 20'-0"
0 10 20 40

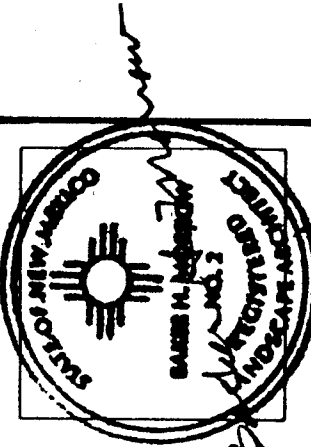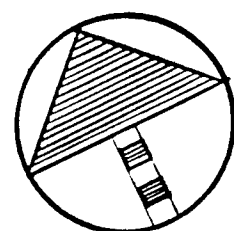

MORROW & COMPANY
LANDSCAPE ARCHITECTS
210 La Veta Drive NE
Albuquerque, New Mexico 87108
505-268-2266



NOVEMBER
1986

AS BUILT

LEAVITT WELL #2
8404 CAMINO SAN MARTIN SW
GRADING PLAN

LANDSCAPING IMPROVEMENTS FOR
WATER SYSTEM FACILITY SITES
WATER SYSTEMS DIVISION
CITY OF ALBUQUERQUE
ALBUQUERQUE, NEW MEXICO

SHEET
51
12

SIDEWALK TRANSITION AS NEEDED
AS PER CITY STD. DTL. P-15

CAMINO SAN MARTIN SW

DRIVE PAD AS PER CITY STD. DETAIL P-11

M
170

PROPOSED 14'-0" DOUBLE-SWING CHAINLINK GATE

PROPOSED CONCRETE SIDEWALK AS PER CITY
STD. DETAIL P-13

A
170

PROPOSED FLUSH HEADER CURB

EXISTING
HEADWALL

ASPHALT PAVING AS PER CITY STD. DETAIL P-8
MATCH WIDTH WITH WIDTH OF EXISTING CURB
CUT ($\pm 14'-0"$).

D
172

PROPOSED CONCRETE
MATCH WIDTH OF PROPOSED CONCRETE WITH
WIDTH OF EXISTING CONCRETE WALK


M
170

6'-0" CHAINLINK FENCE
LOCATE CHAINLINK FENCE ON PROPERTY LINE.
LOCATE CHAINLINK FENCE ALONG NORTH EDGE
DIRECTLY ADJACENT TO PROPOSED SIDEWALK.

ALIGN OUTSIDE EDGE OF FLUSH HEADER CURB
WITH SOUTH EDGE OF BUILDING AS SHOWN.

WELL #2

SCALE 1" 20'-0"
0 10 20 40

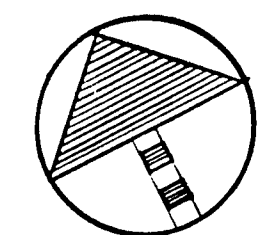

MORROW & COMPANY
LANDSCAPE ARCHITECTS
210 La Veta Drive NE
Albuquerque, New Mexico 87108
505-268-2266

NOVEMBER
1986


AS BUILT

LEAVITT WELL #2
8404 CAMINO SAN MARTIN SW
CONSTRUCTION PLAN

LANDSCAPING IMPROVEMENTS FOR
WATER SYSTEM FACILITY SITES
WATER SYSTEMS DIVISION
CITY OF ALBUQUERQUE
ALBUQUERQUE, NEW MEXICO



SHEET
172

26 3097 4486

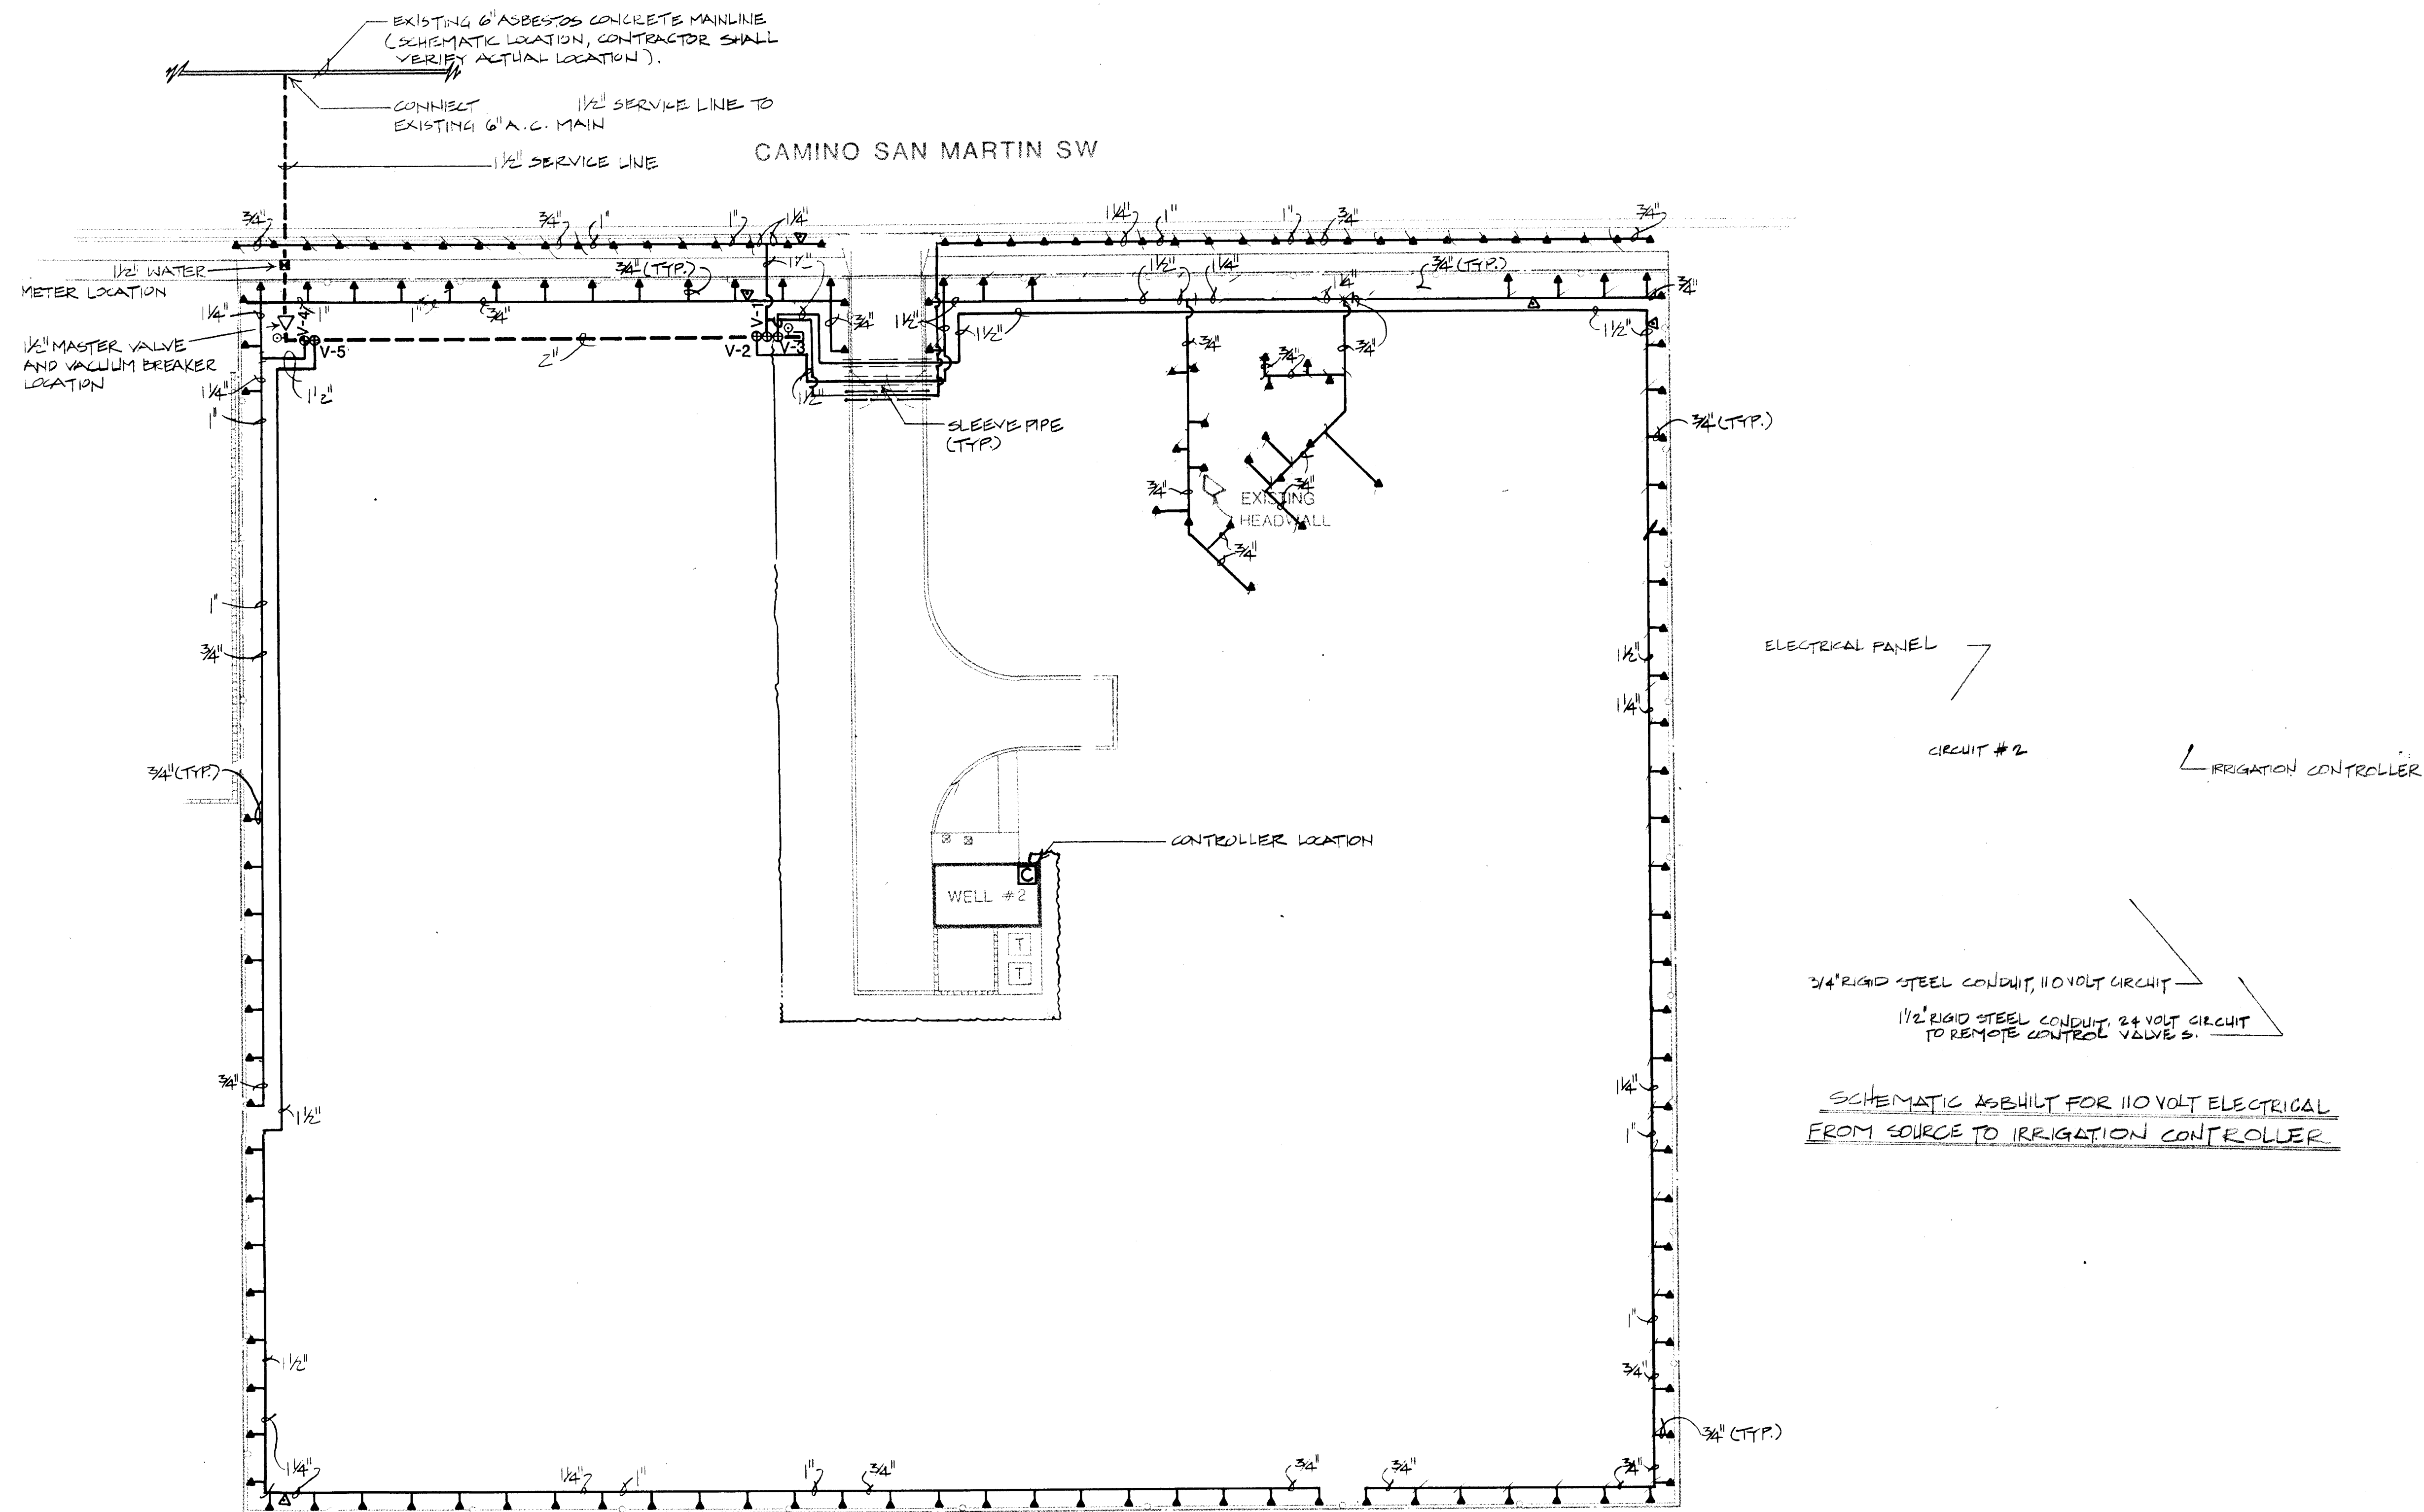


26 3097 4586

SCALE 1" 20'-0"
0 10 20 40

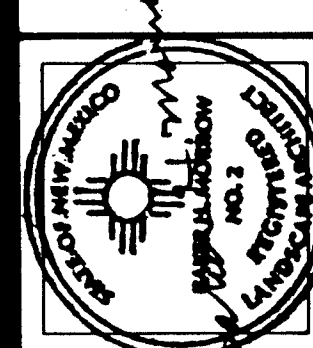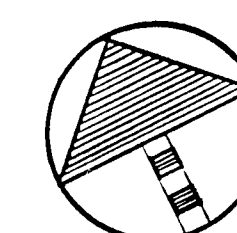

MORROW & COMPANY
LANDSCAPE ARCHITECTS
210 La Veta Drive NE
Albuquerque, New Mexico 87108
505-268-2266

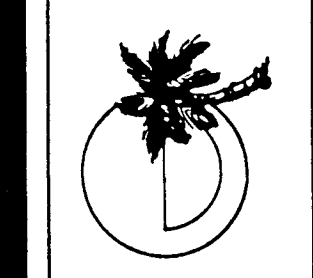


NOVEMBER
1986

AS BUILT

LEAVITT WELL #2
8404 CAMINO SAN MARTIN SW
IRRIGATION PLAN



LANDSCAPING IMPROVEMENTS FOR
WATER SYSTEM FACILITY SITES
WATER SYSTEMS DIVISION
CITY OF ALBUQUERQUE
ALBUQUERQUE, NEW MEXICO

SHEET
33
15
12

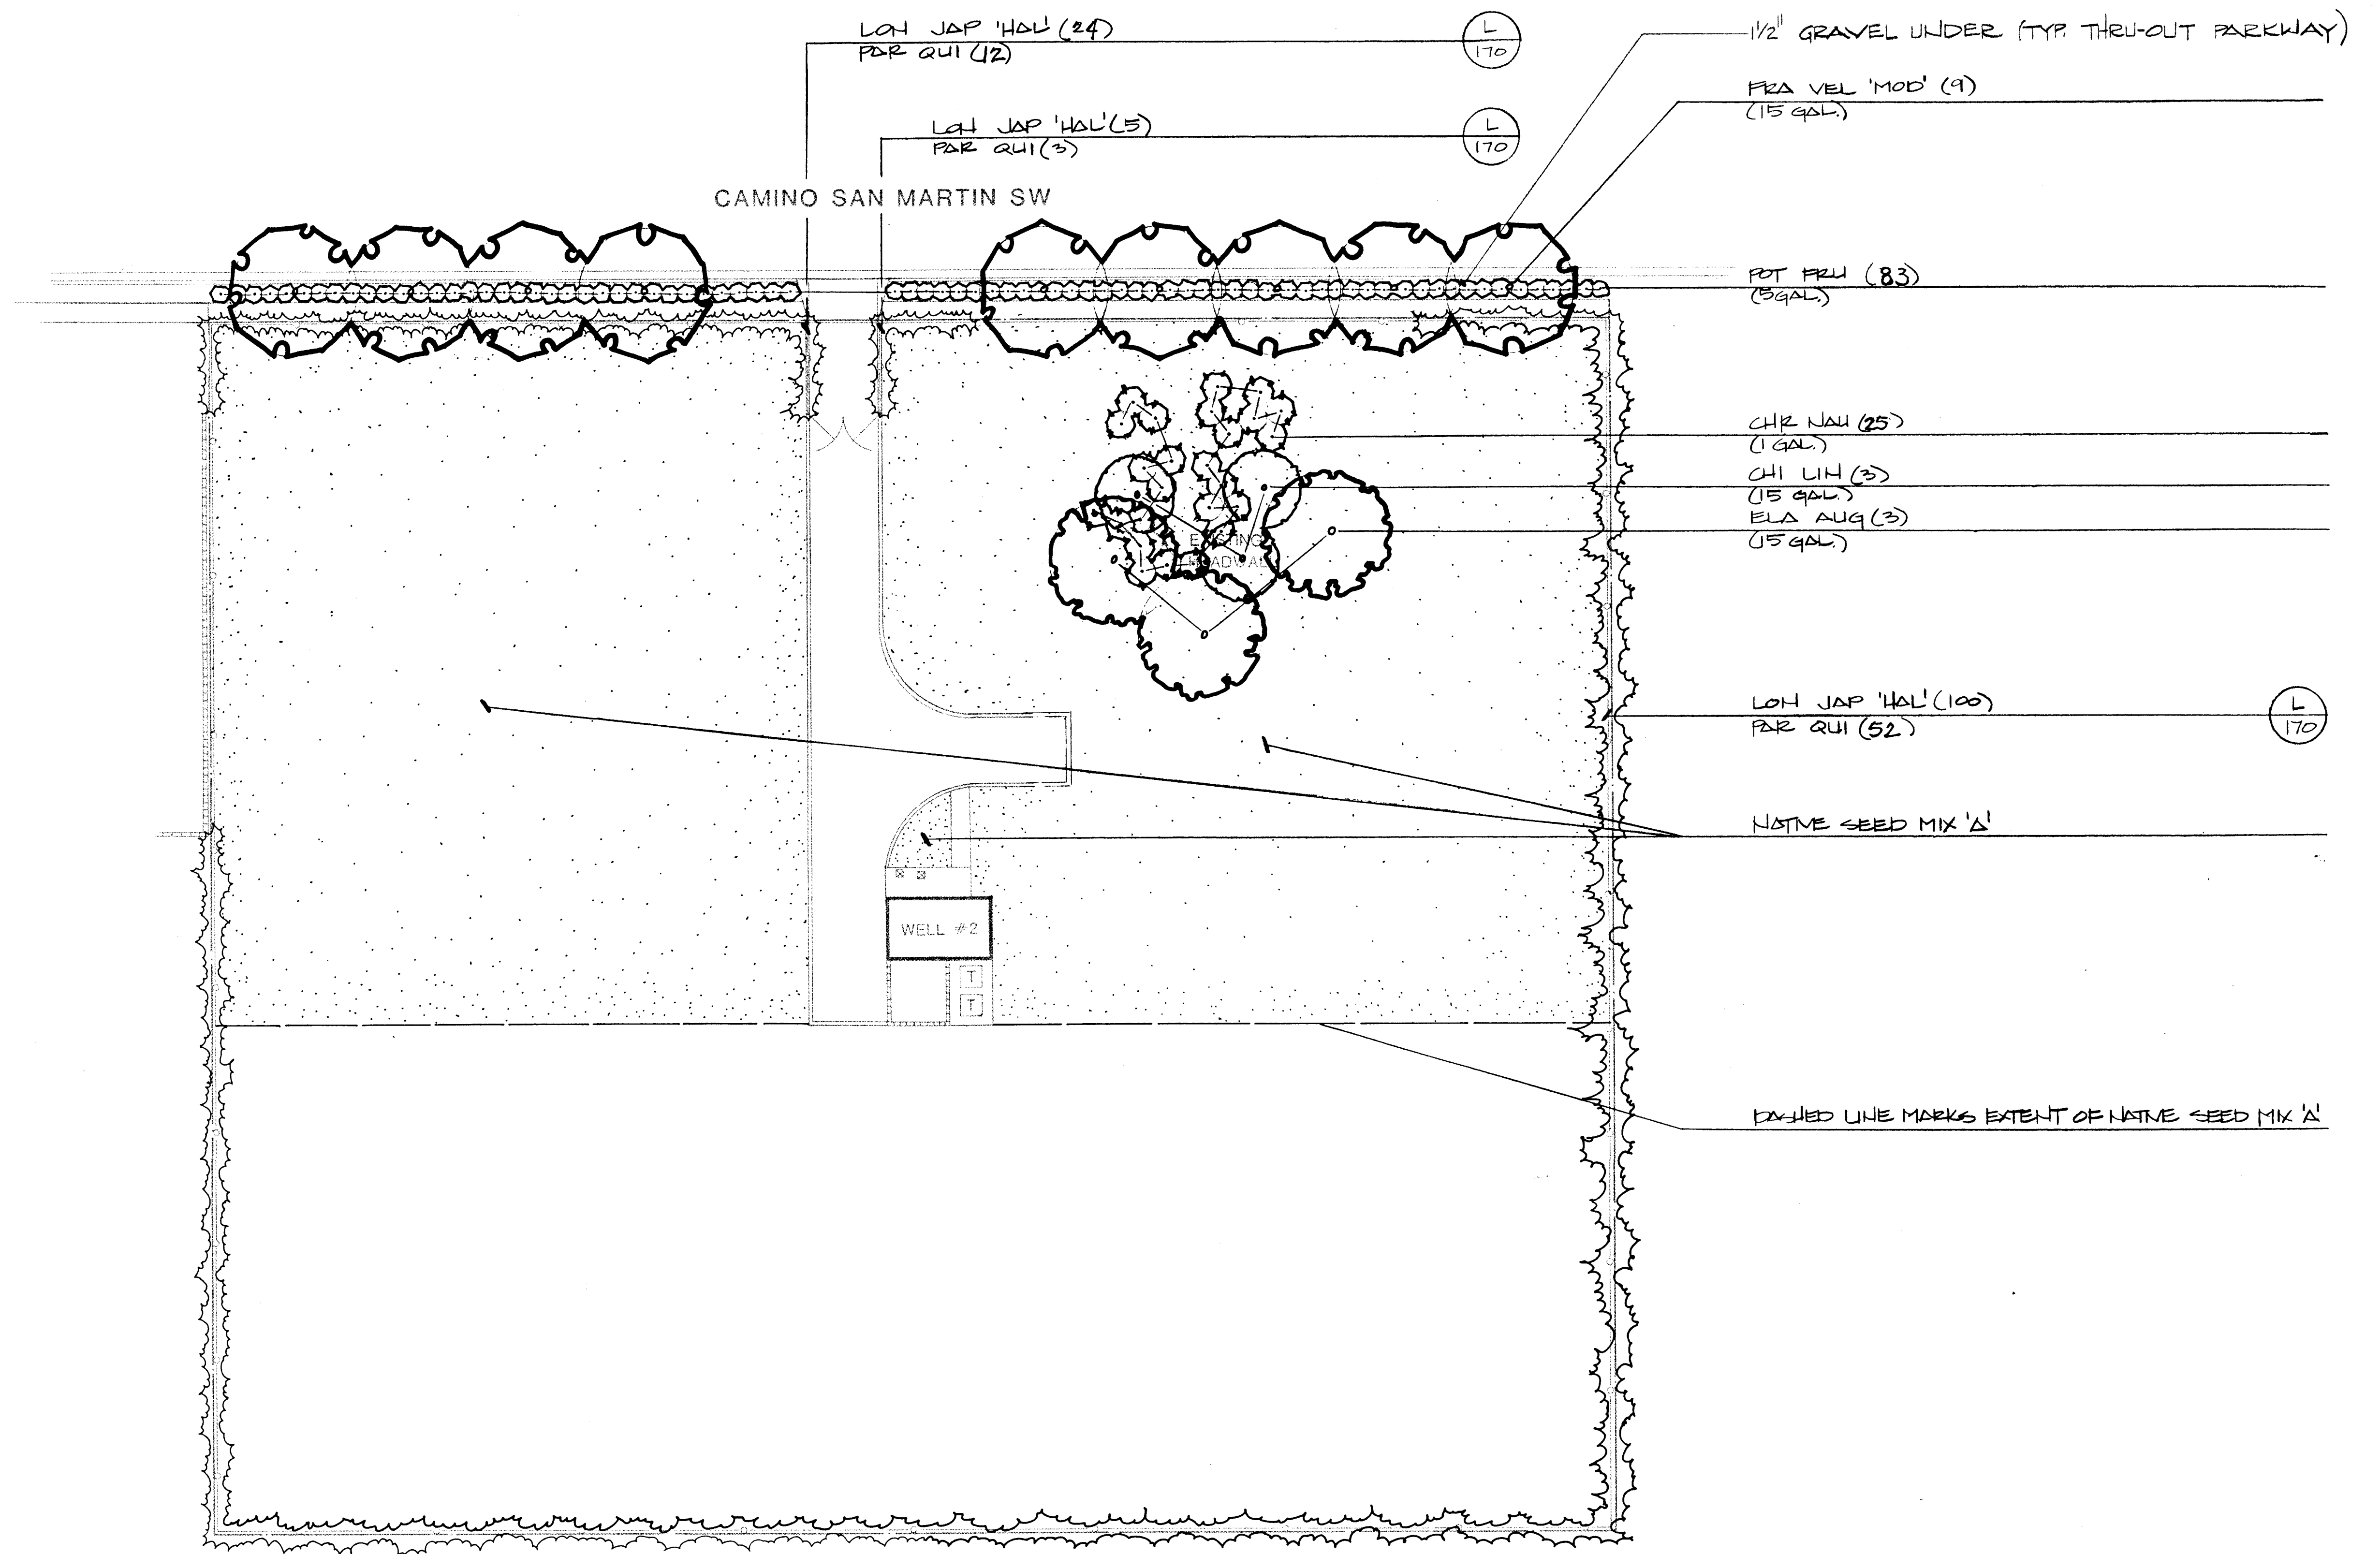


26 3097 4686

SCALE 1" 20'-0"

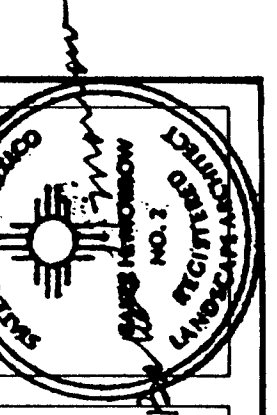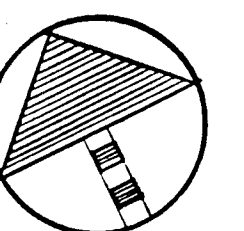

MORROW & COMPANY
LANDSCAPE ARCHITECTS
210 La Veta Drive NE
Albuquerque, New Mexico 87108
505-266-2266

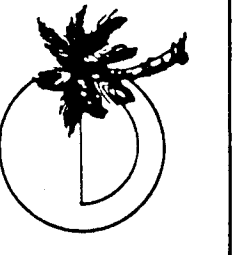


NOVEMBER
1986

AS BUILT

LEAVITT WELL #2
8404 CAMINO SAN MARTIN SW
PLANTING PLAN

LANDSCAPING IMPROVEMENTS FOR
WATER SYSTEM FACILITY SITES
WATER SYSTEMS DIVISION
CITY OF ALBUQUERQUE
ALBUQUERQUE, NEW MEXICO

SHEET
172

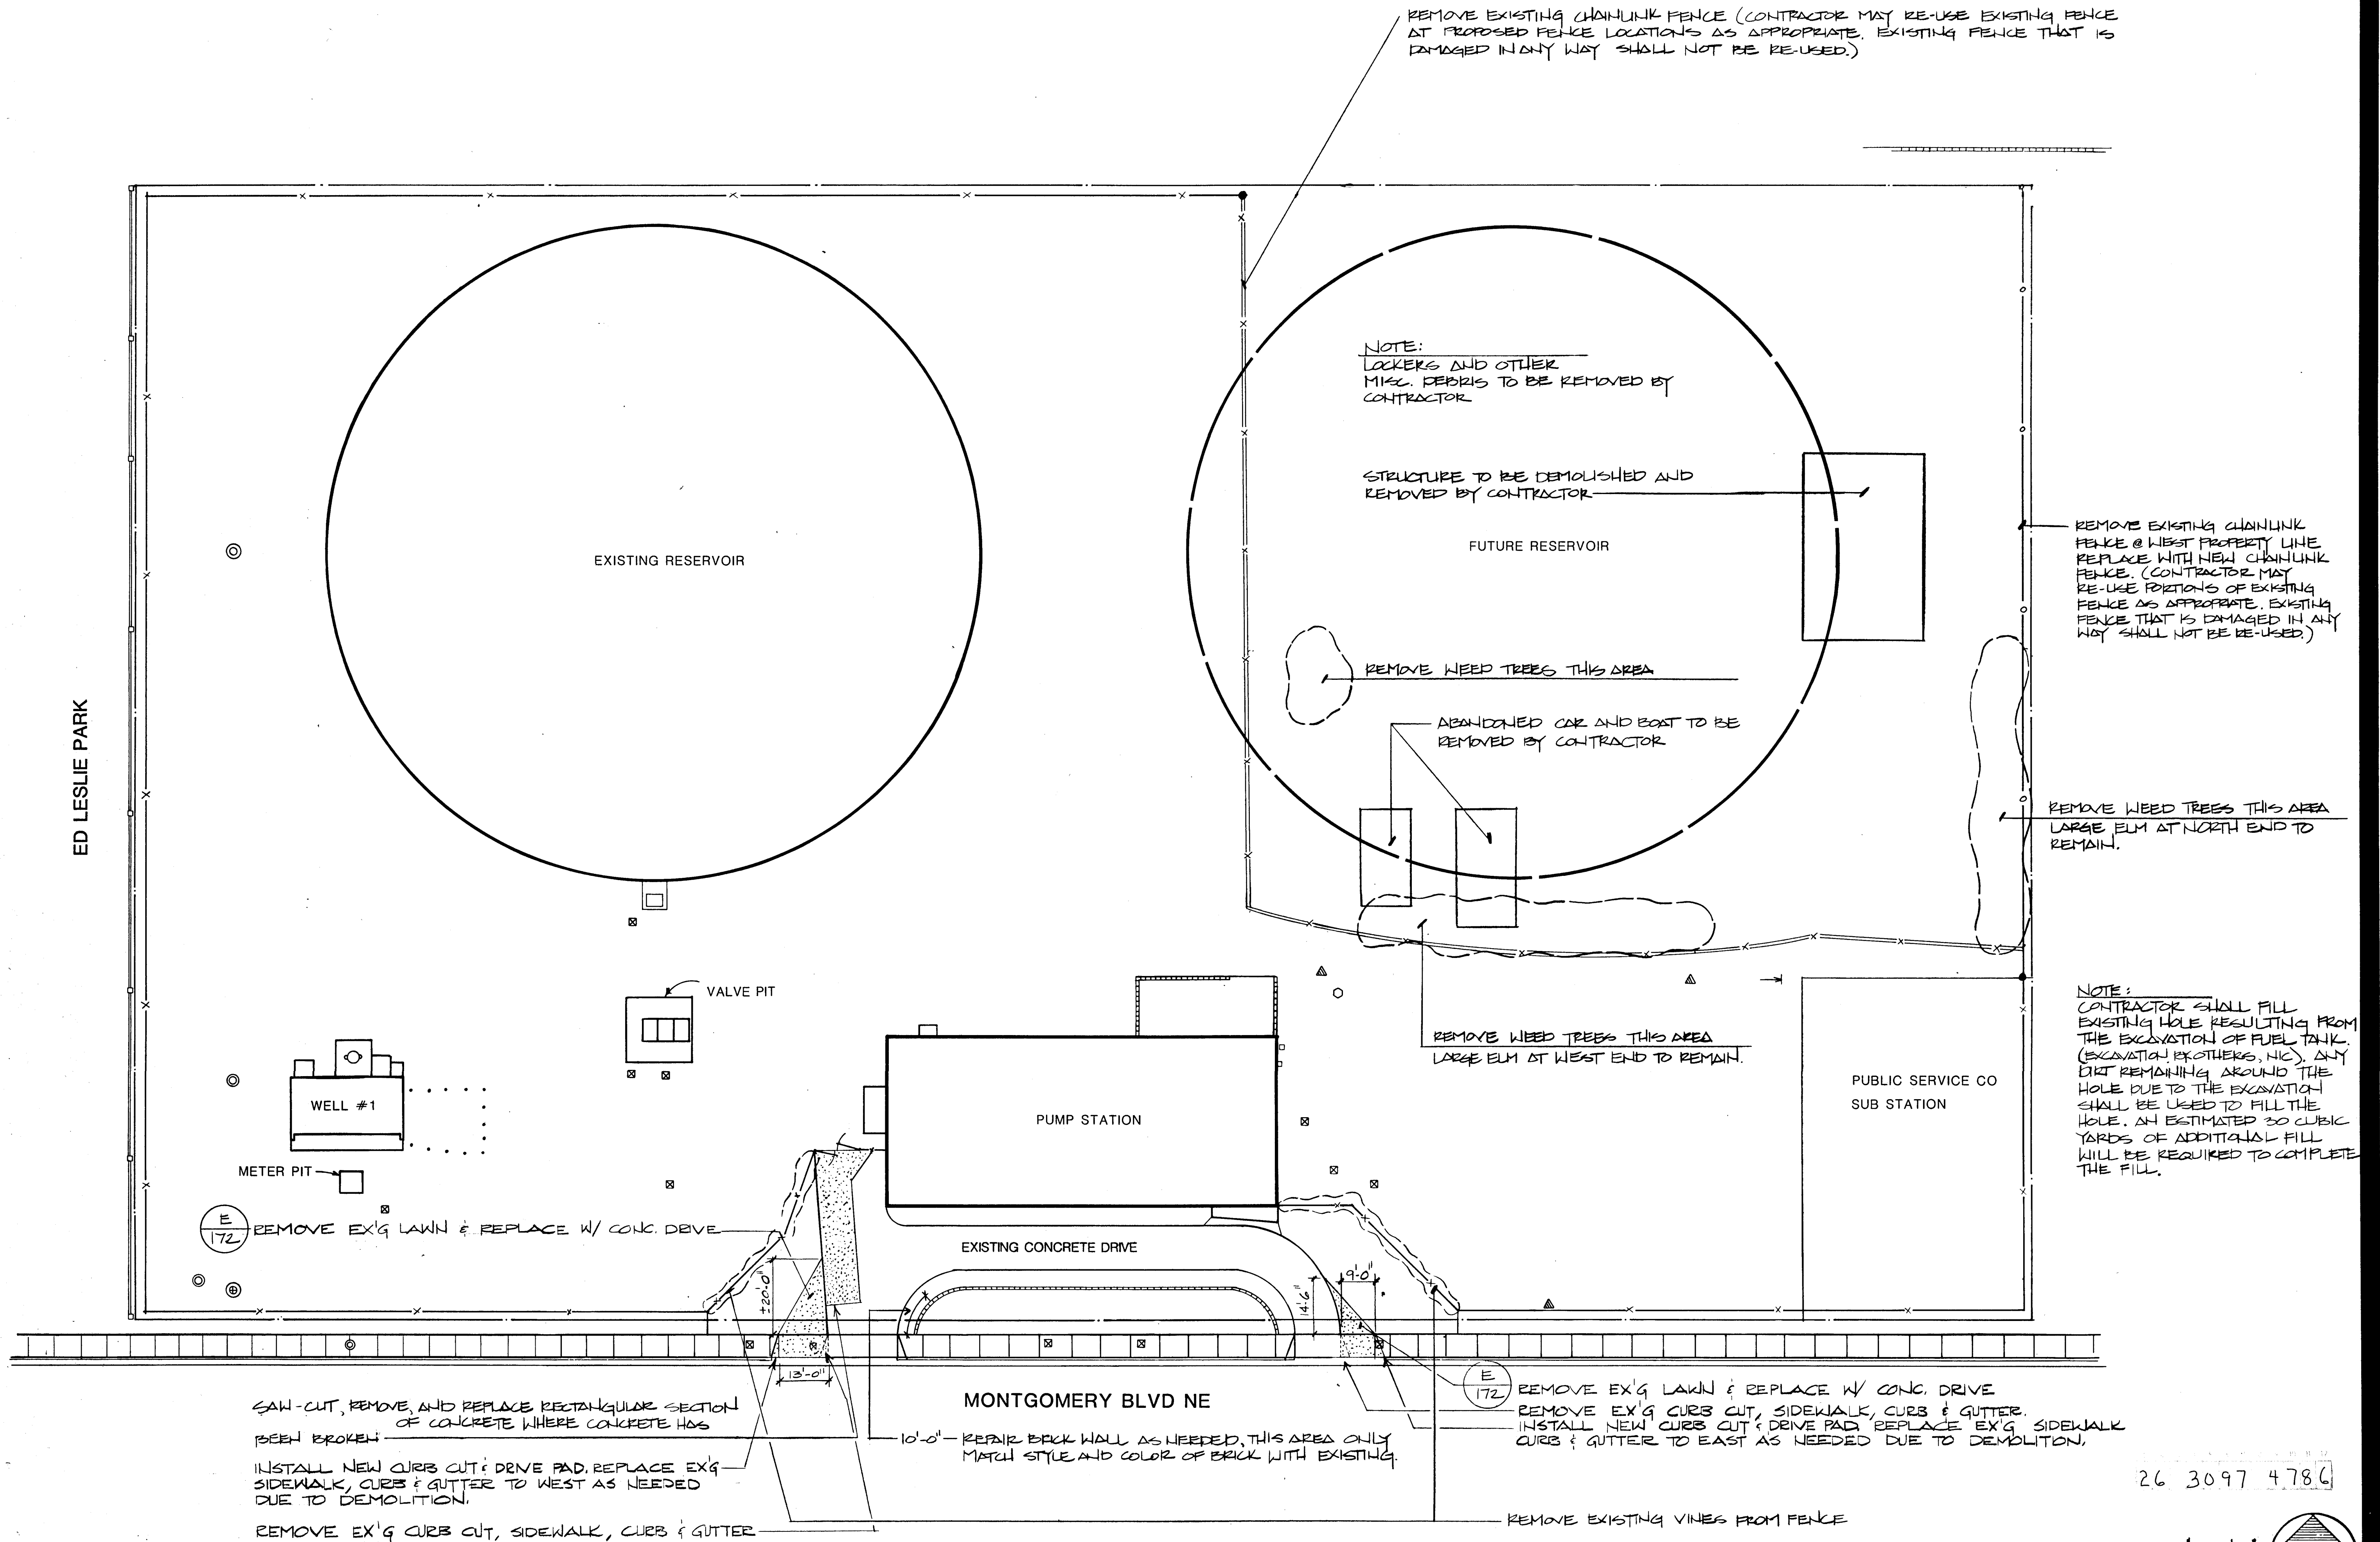



NOTE:

- DRIVE PADS AS PER CITY STD. DTL. P-11
- SIDEWALK AS PER CITY STD. DTL. P-13
- CURB & GUTTER AS PER CITY STD. DTL. P-8
- ADJUST HEIGHT OF METER & VALVE BOXES AS NEEDED. CHANGE
BOXES TO HEAVY WEIGHT COVER & LID AS PER CITY STD. DTL. W-19

SCALE 1"=20'-0"

0 10 20 40

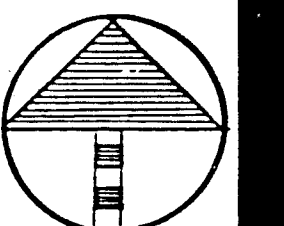

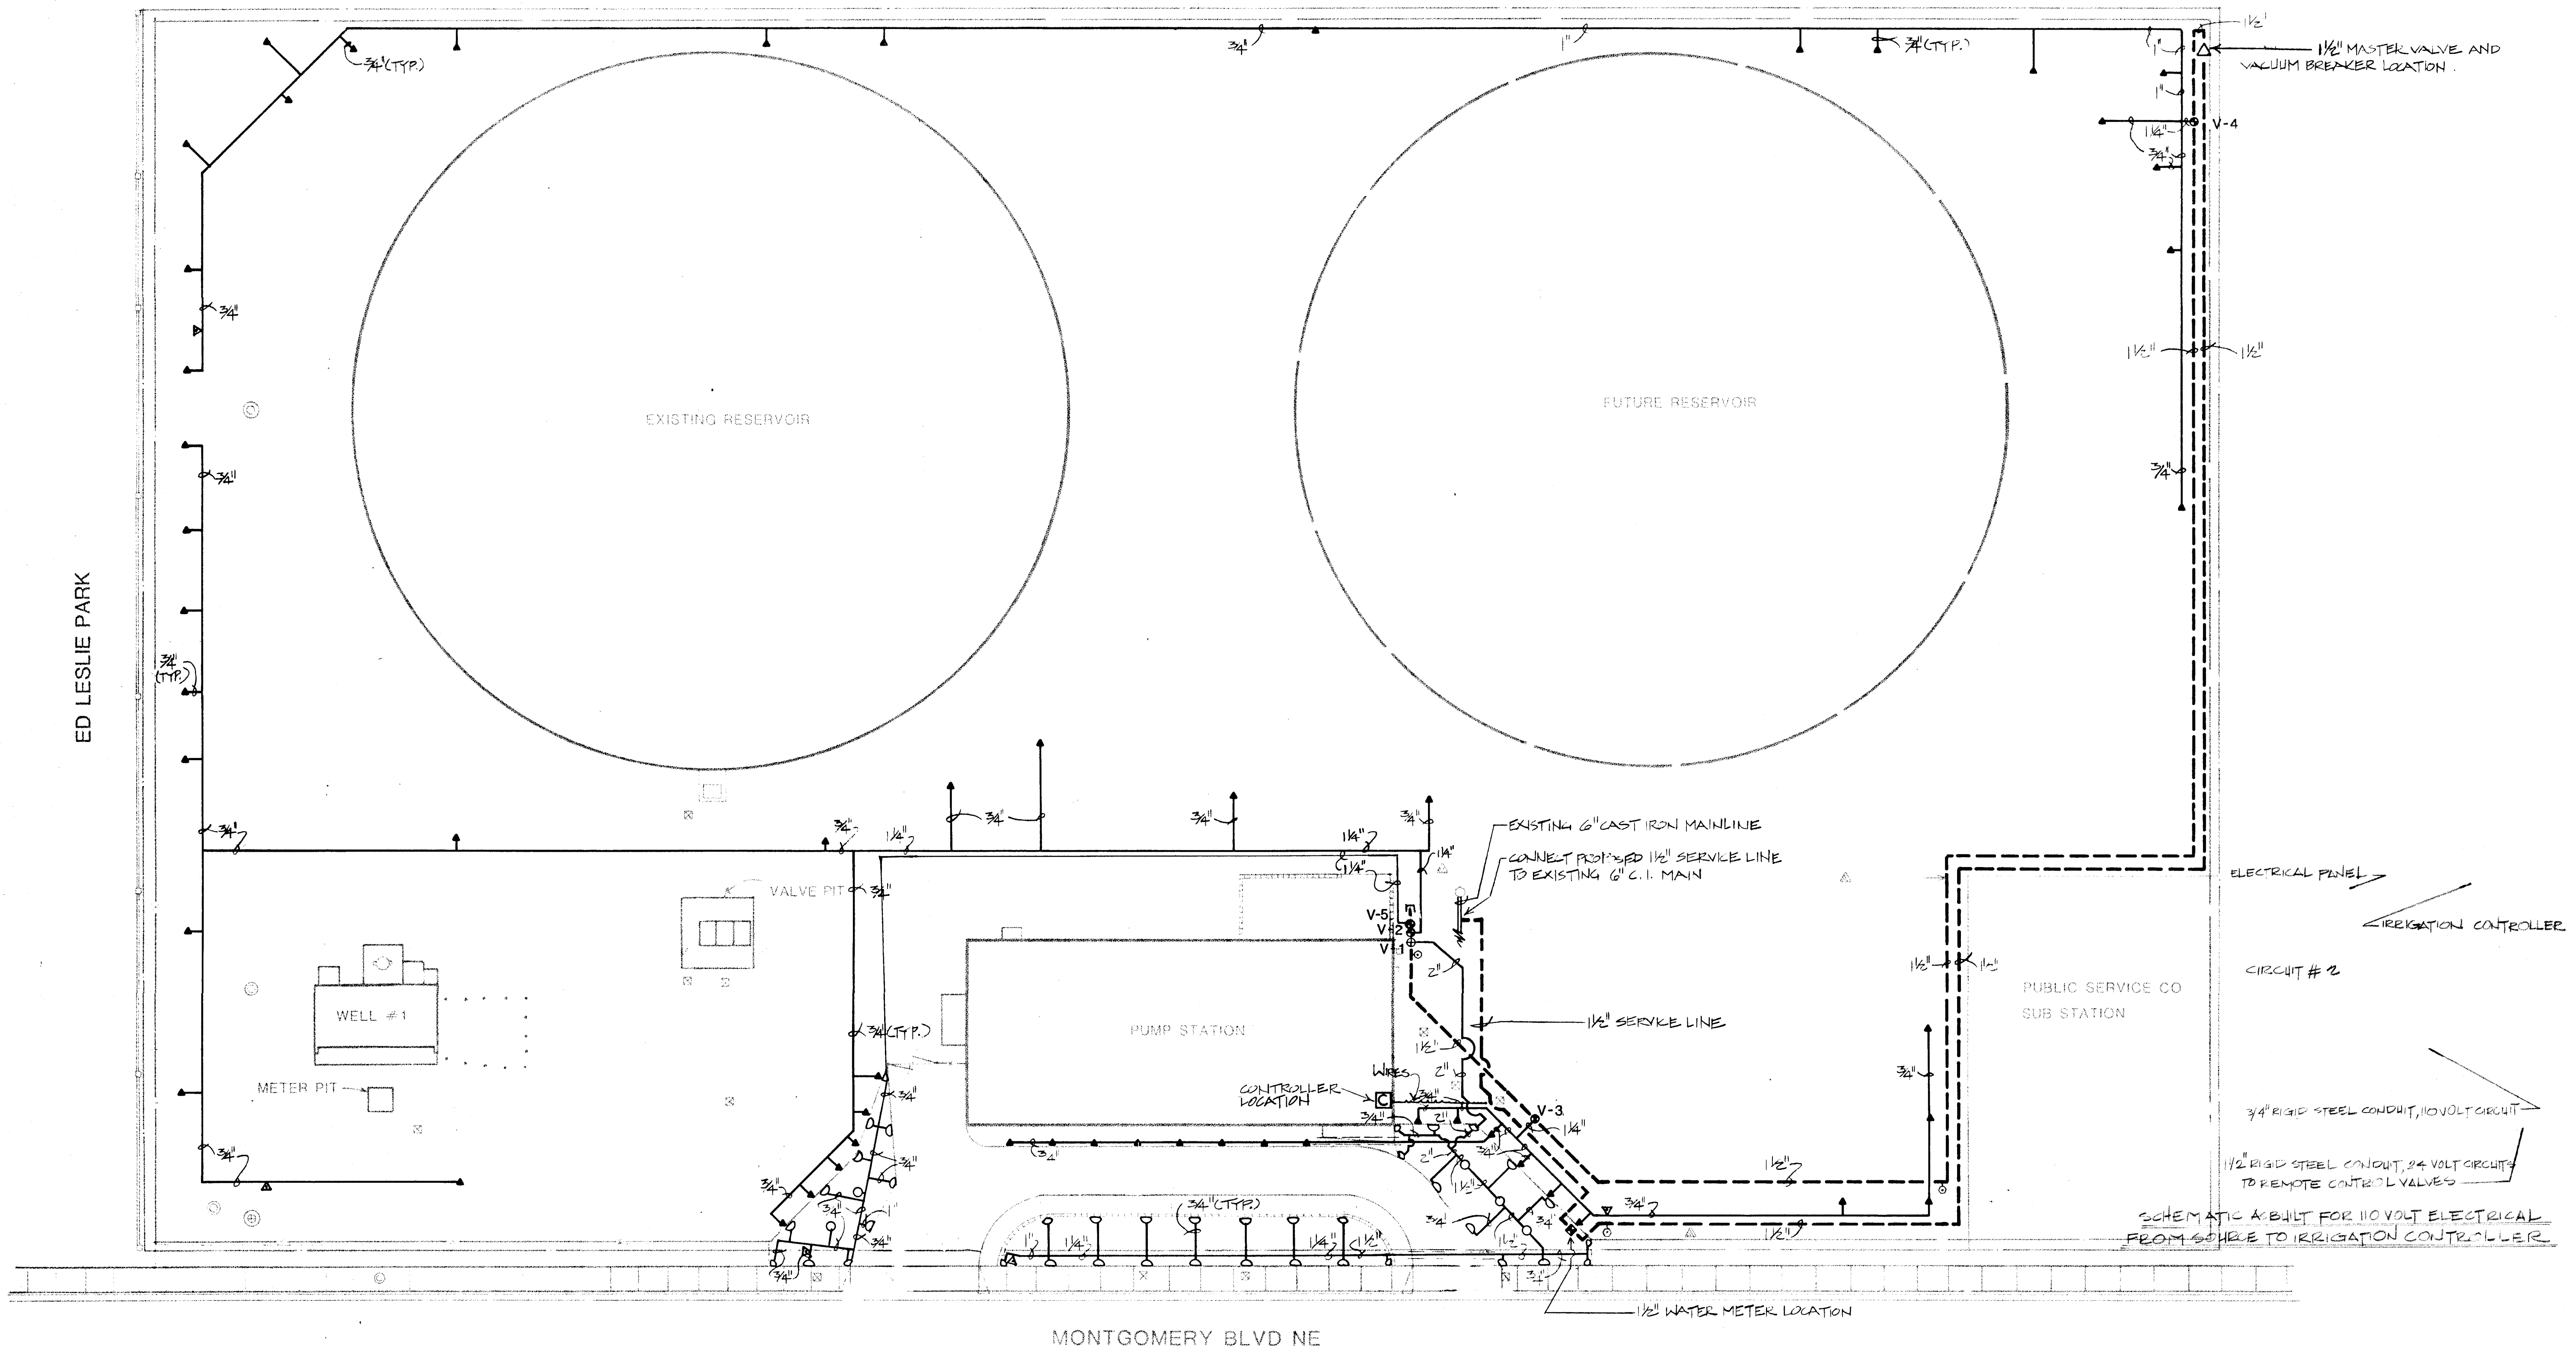


ED LESLIE PARK

MONTGOMERY BLVD NE

26 3097 4886

SCALE 1"=20'-0"
0 10 20 40

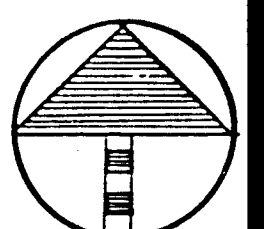



MORROW & COMPANY
LANDSCAPE ARCHITECTS
210 La Veta Drive NE
Albuquerque, New Mexico 87108
505-268-2266

NOVEMBER
1986

LEYENDECKER WELL #1 & RESERVOIR
6901 MONTGOMERY BLVD. NE
AS BUILT
IRRIGATION PLAN

LANDSCAPING IMPROVEMENTS FOR
WATER SYSTEM FACILITY SITES
WATER SYSTEMS DIVISION
CITY OF ALBUQUERQUE
ALBUQUERQUE, NEW MEXICO

SHEET
56
97
172

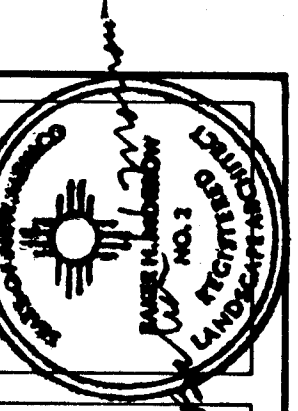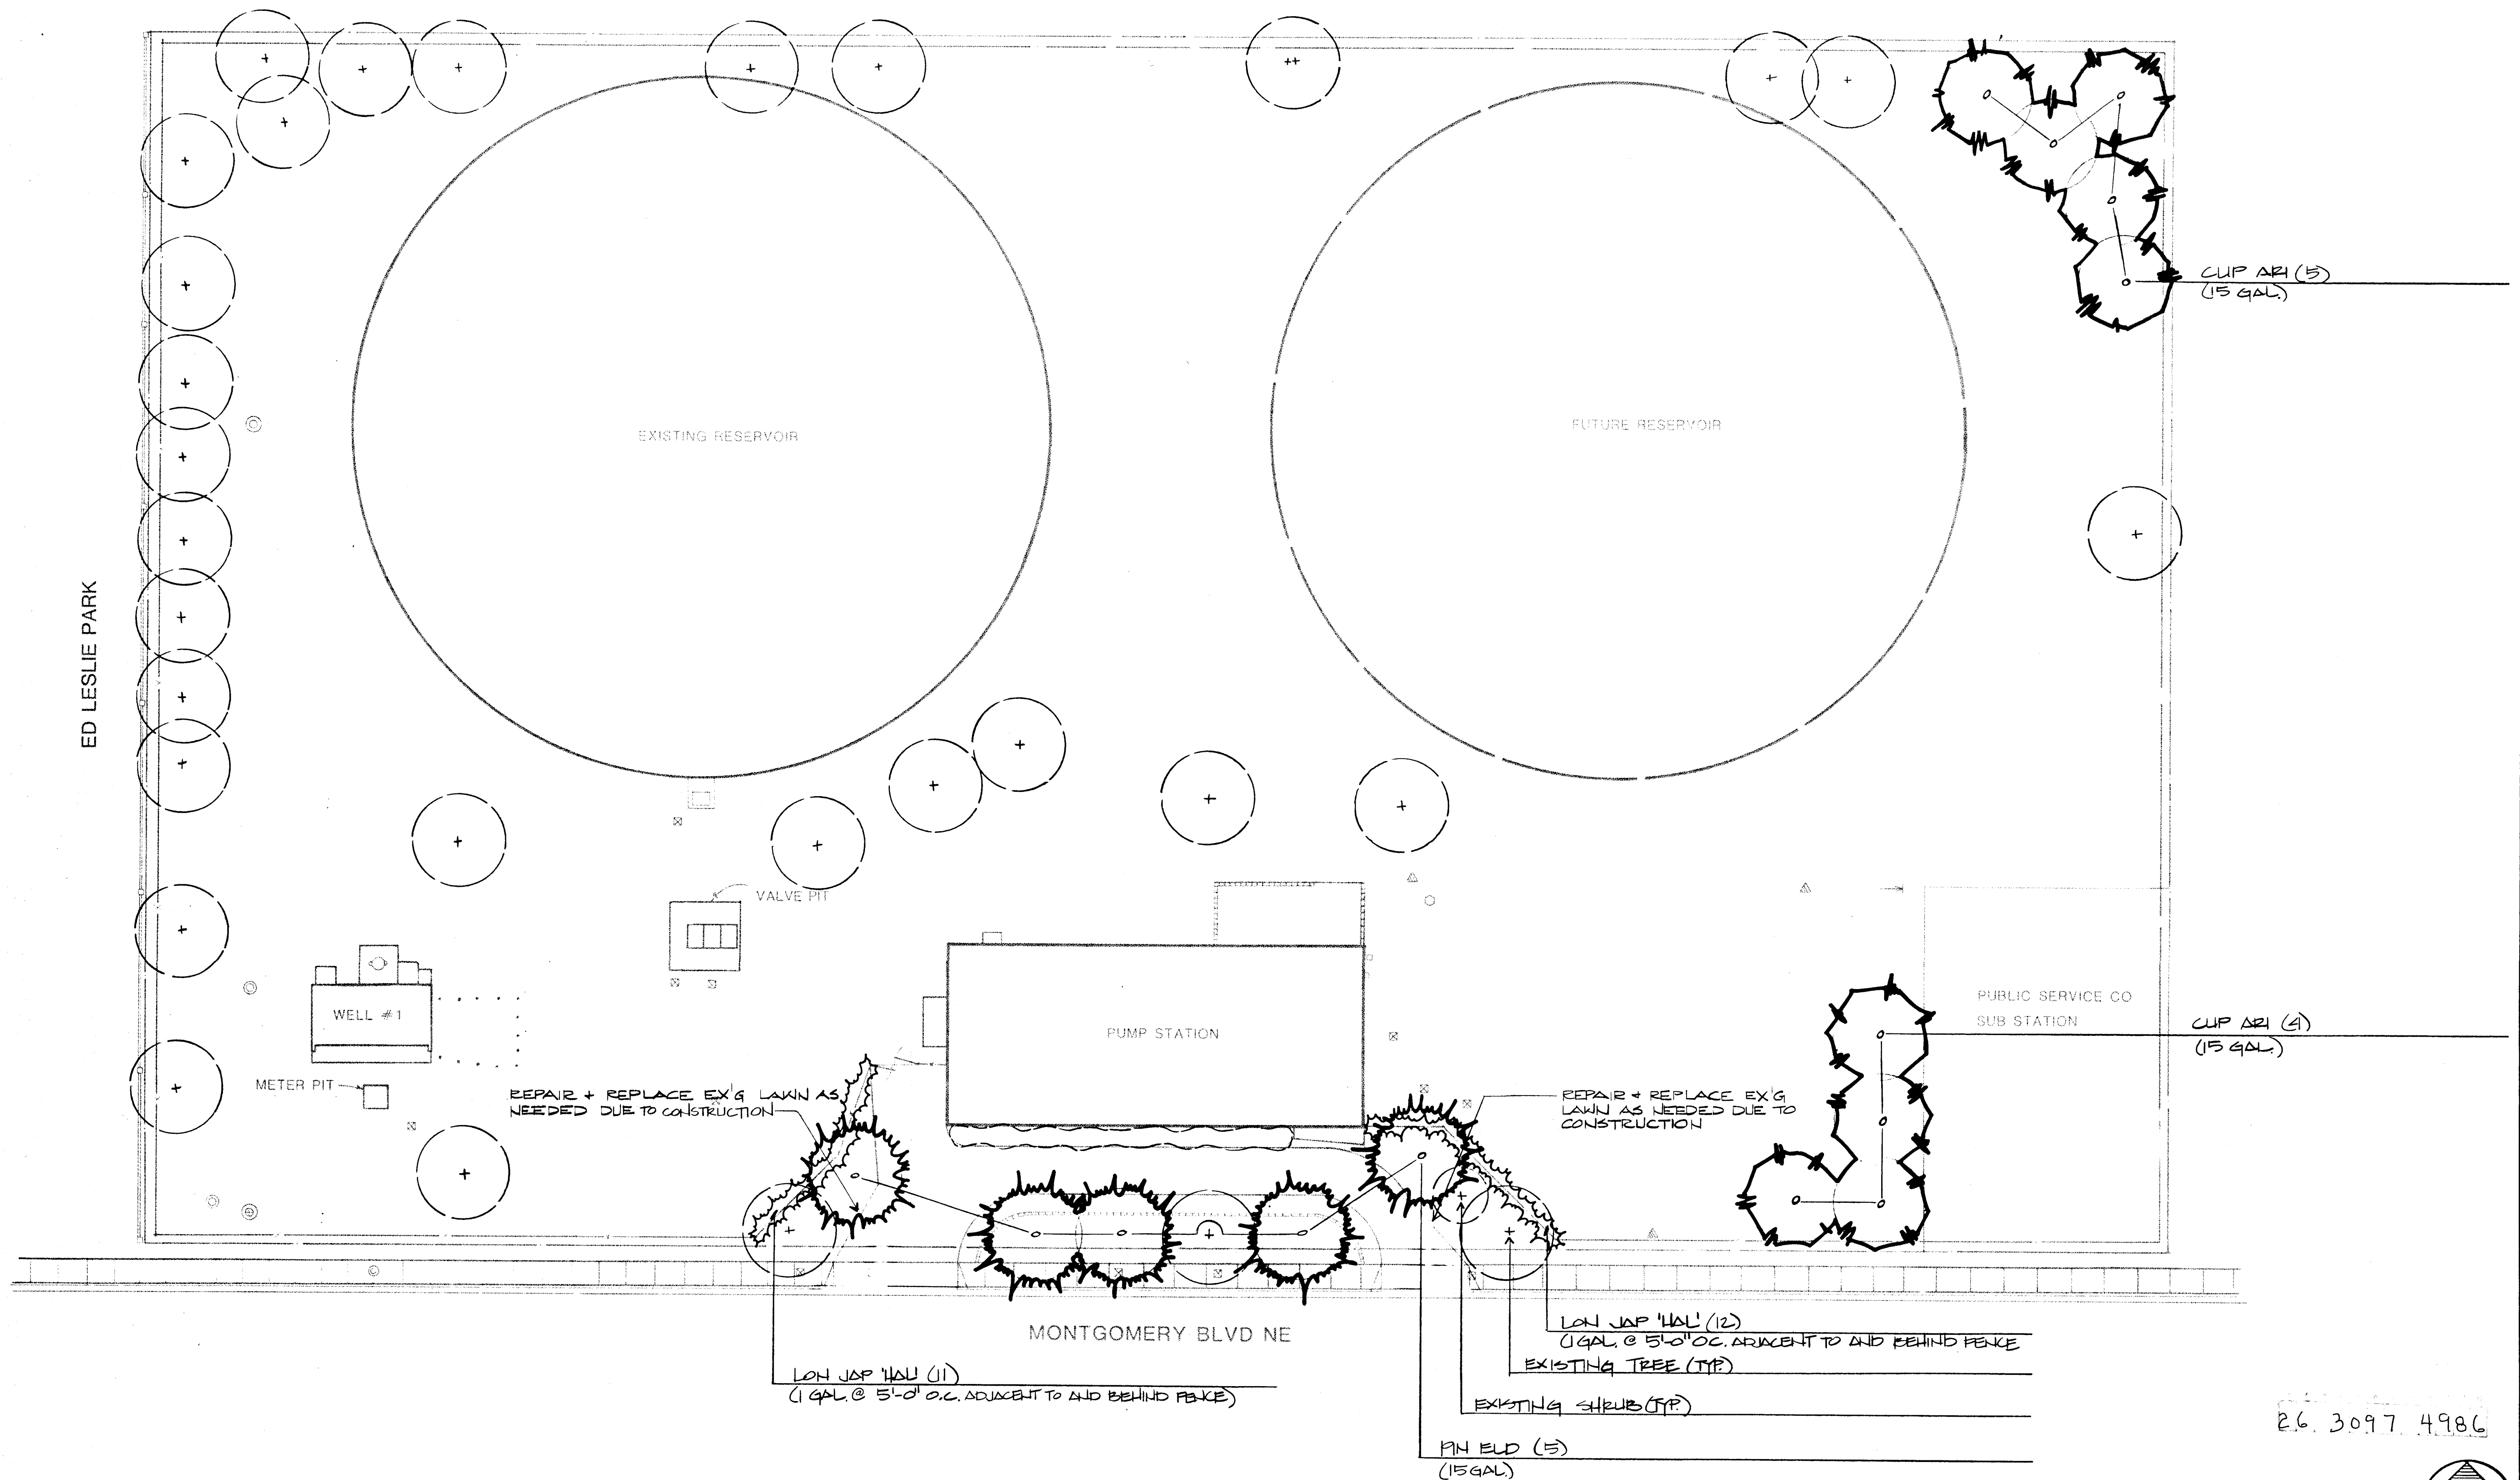

MORROW & COMPANY
LANDSCAPE ARCHITECTS
210 La Veta Drive NE
Albuquerque, New Mexico 87108
505-268-2266




NOVEMBER
1986

LEYENDECKER WELL #1 & RESERVOIR
6901 MONTGOMERY BLVD. NE
AS BUILT
PLANTING PLAN

LANDSCAPING IMPROVEMENTS FOR
WATER SYSTEM FACILITY SITES
WATER SYSTEMS DIVISION
CITY OF ALBUQUERQUE
ALBUQUERQUE, NEW MEXICO



SHEET
91
172

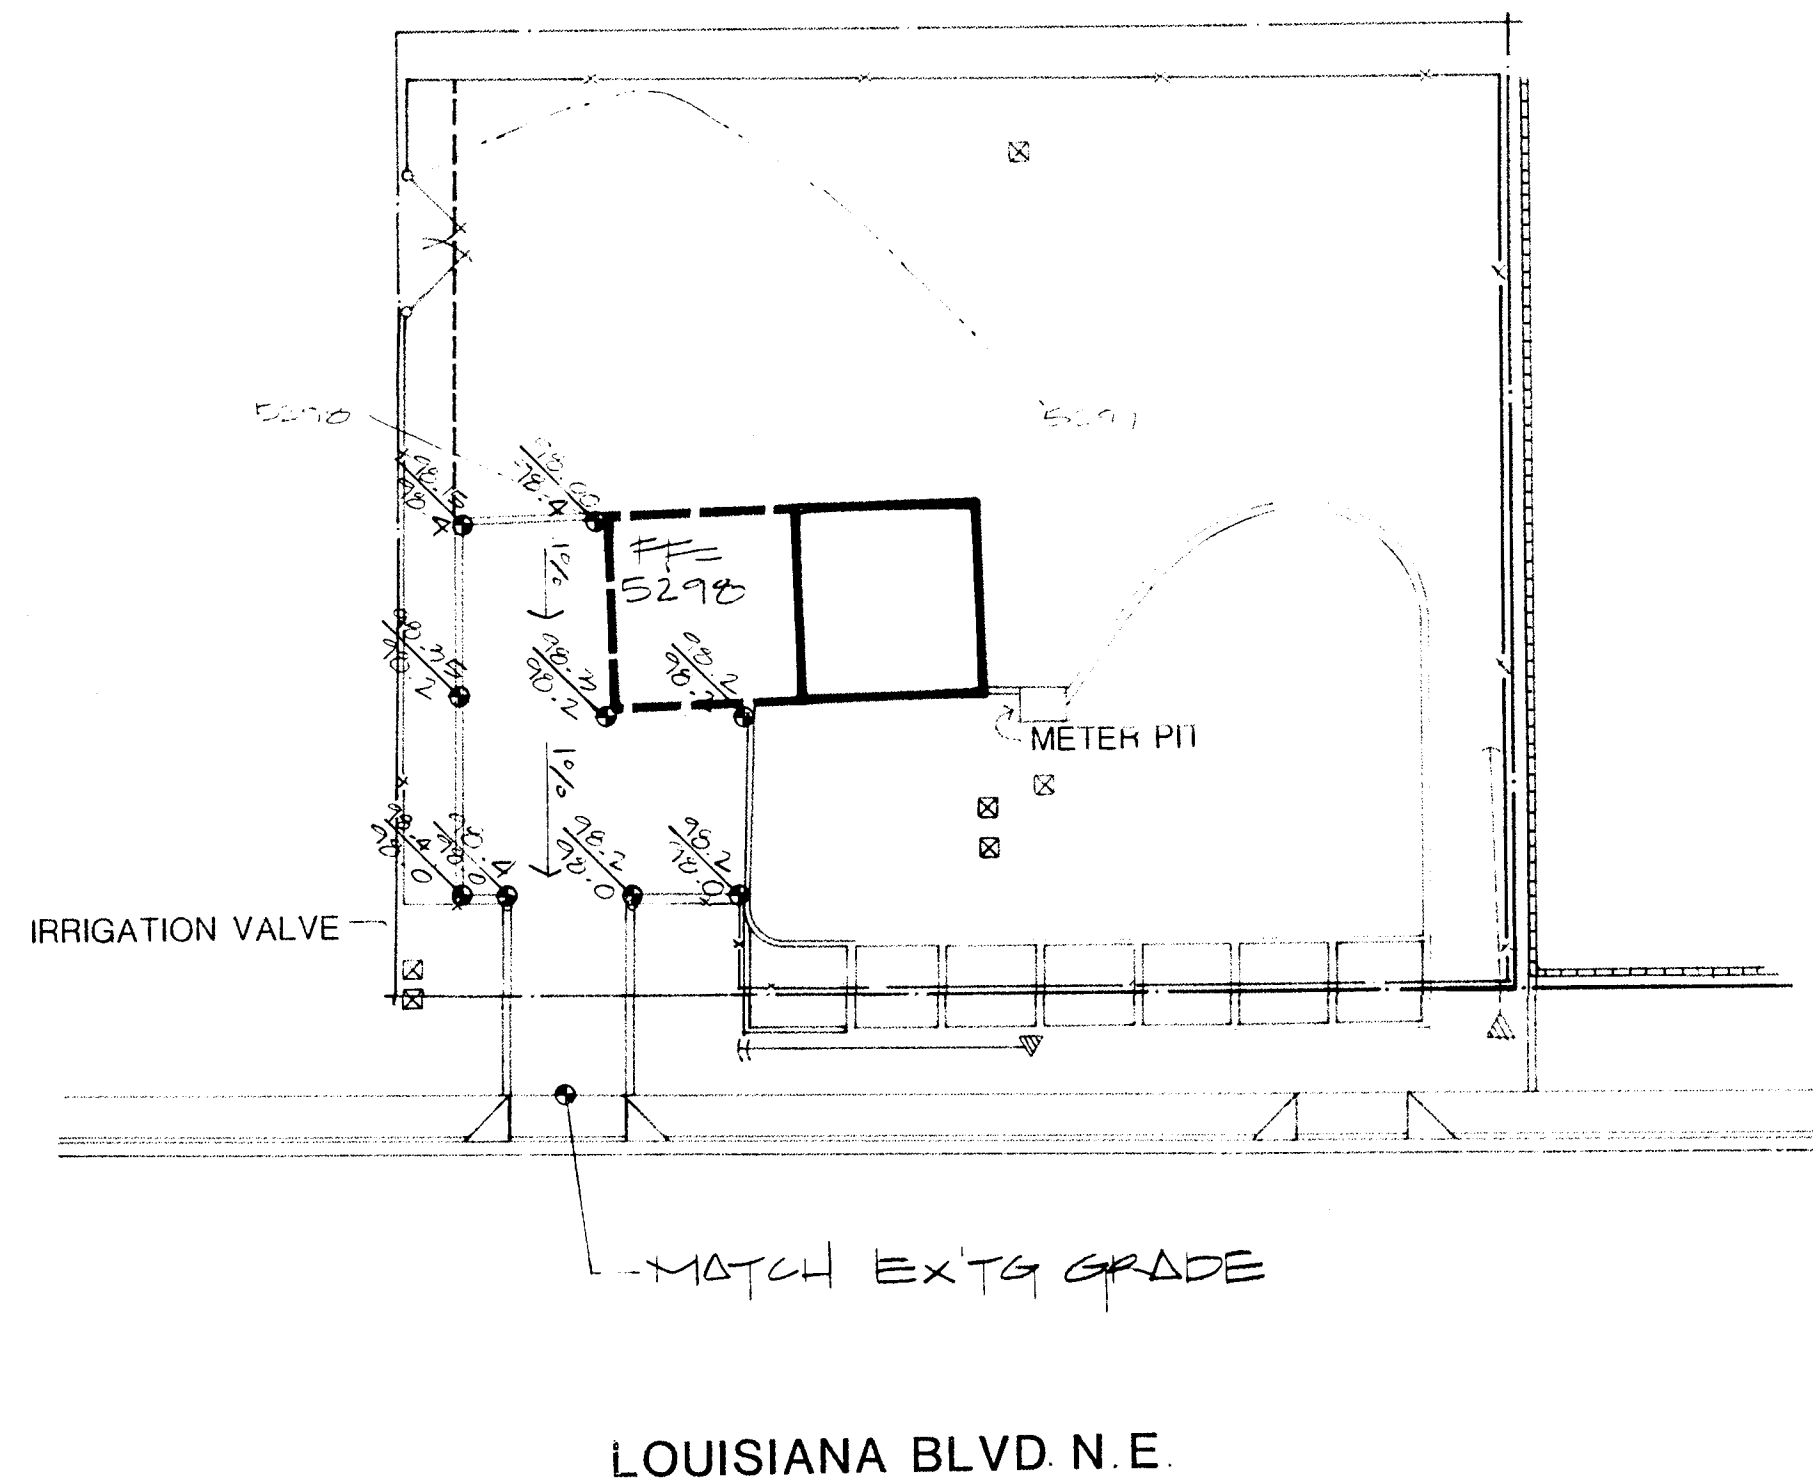

26 3097 5086

SCALE 1"=20'-0"

0 10 20 40

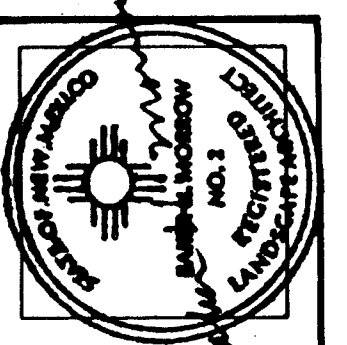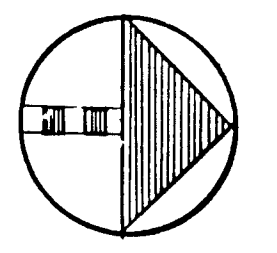

MORROW & COMPANY
 LANDSCAPE ARCHITECTS
 210 La Veta Drive NE
 Albuquerque, New Mexico 87108
 505-268-2266


NOVEMBER
 1986

LEYENDECKER WELL #2
 3617 LOUISIANA BLVD. NE
 GRADING PLAN

AS BUILT

LANDSCAPING IMPROVEMENTS FOR
WATER SYSTEM FACILITY SITES
 WATER SYSTEMS DIVISION
 CITY OF ALBUQUERQUE
 ALBUQUERQUE, NEW MEXICO


SHEET
 88
 172

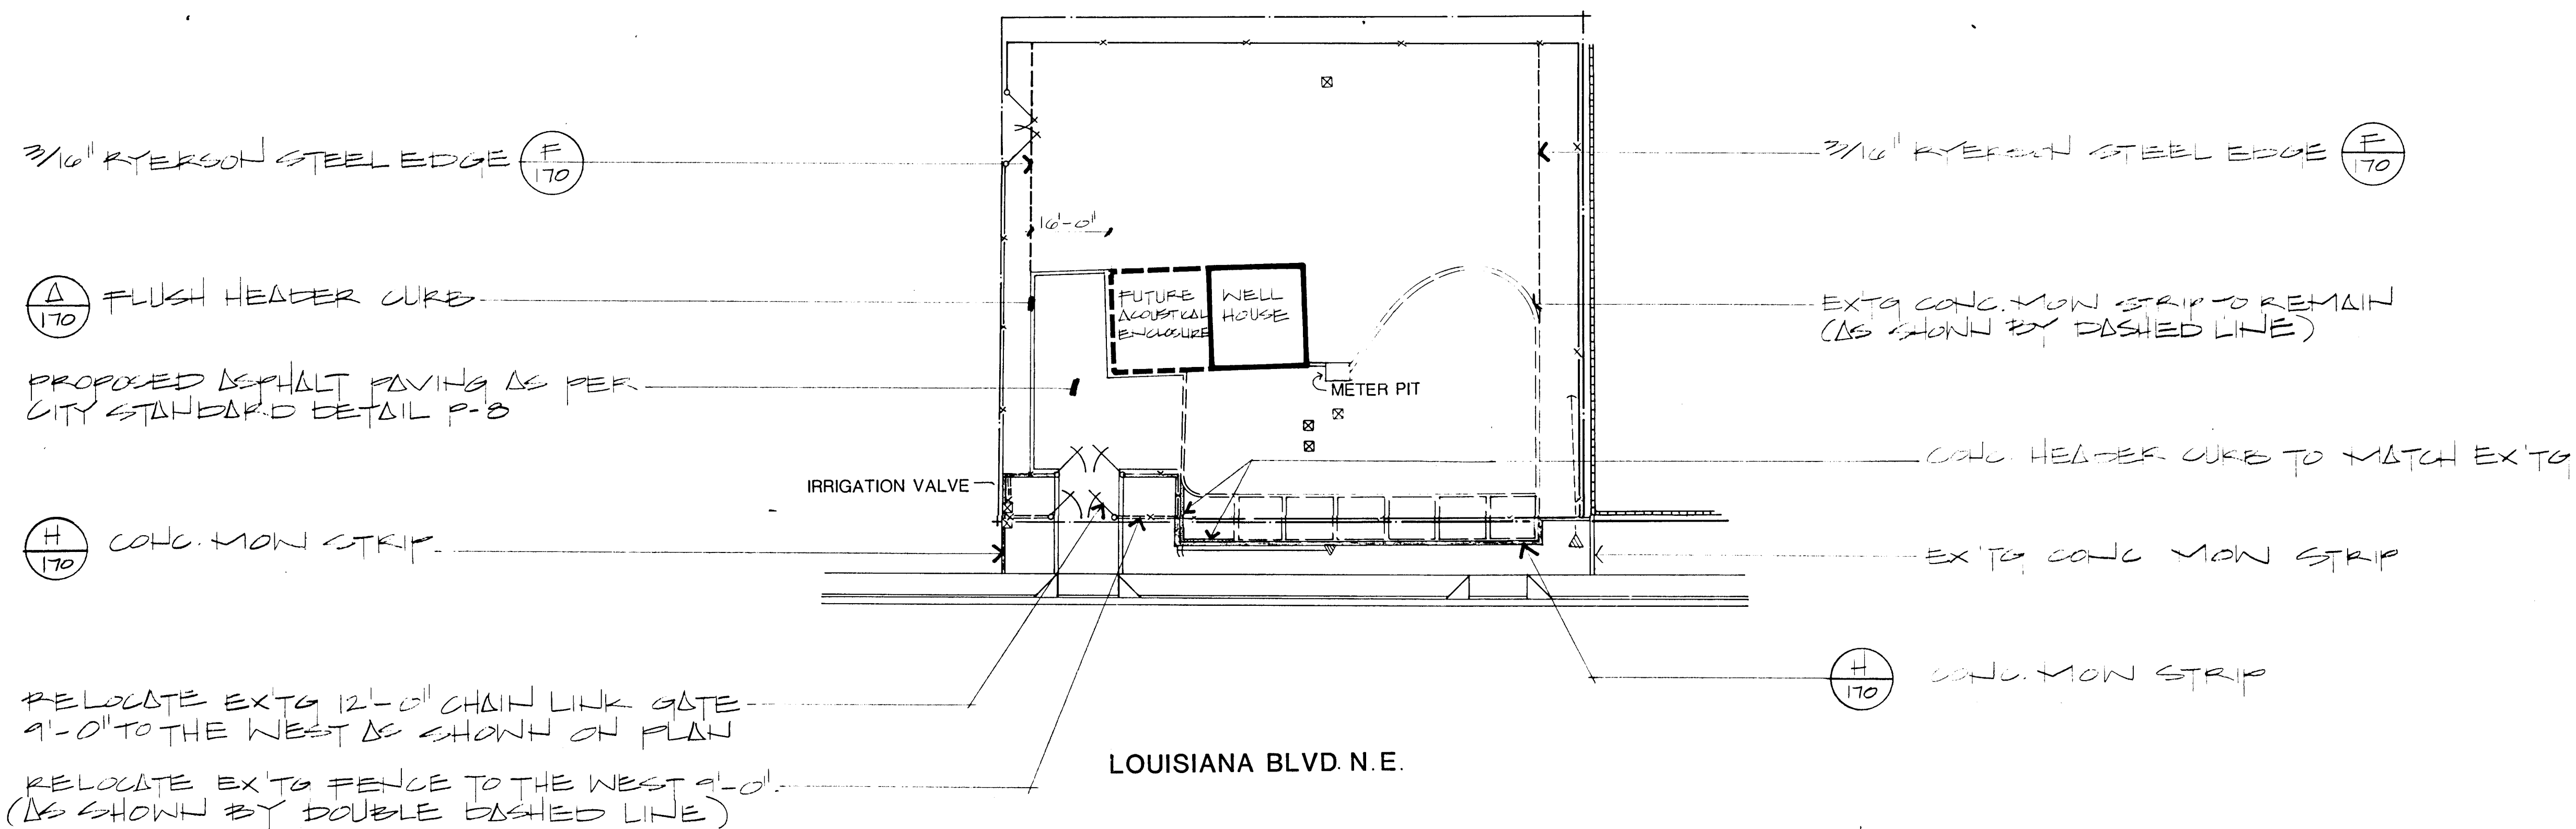

NOTE:
FOR DEMOLITION OF PLANT MATERIAL
SEE PLANTING PLAN

26 3097 5186

SCALE 1"=20'-0"
0 10 20 40

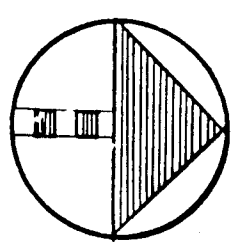

LEYENDECKER WELL #2
3617 LOUISIANA BLVD. NE
CONSTRUCTION PLAN


LANDSCAPING IMPROVEMENTS FOR
WATER SYSTEM FACILITY SITES
WATER SYSTEMS DIVISION
CITY OF ALBUQUERQUE
ALBUQUERQUE, NEW MEXICO



SHEET
59
OF
172

NOVEMBER
1986

AS BUILT

MORROW & COMPANY
LANDSCAPE ARCHITECTS
210 La Veta Drive NE
Albuquerque, New Mexico 87108
505-268-2266

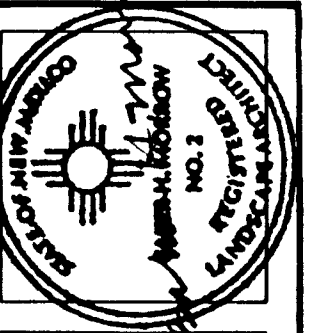


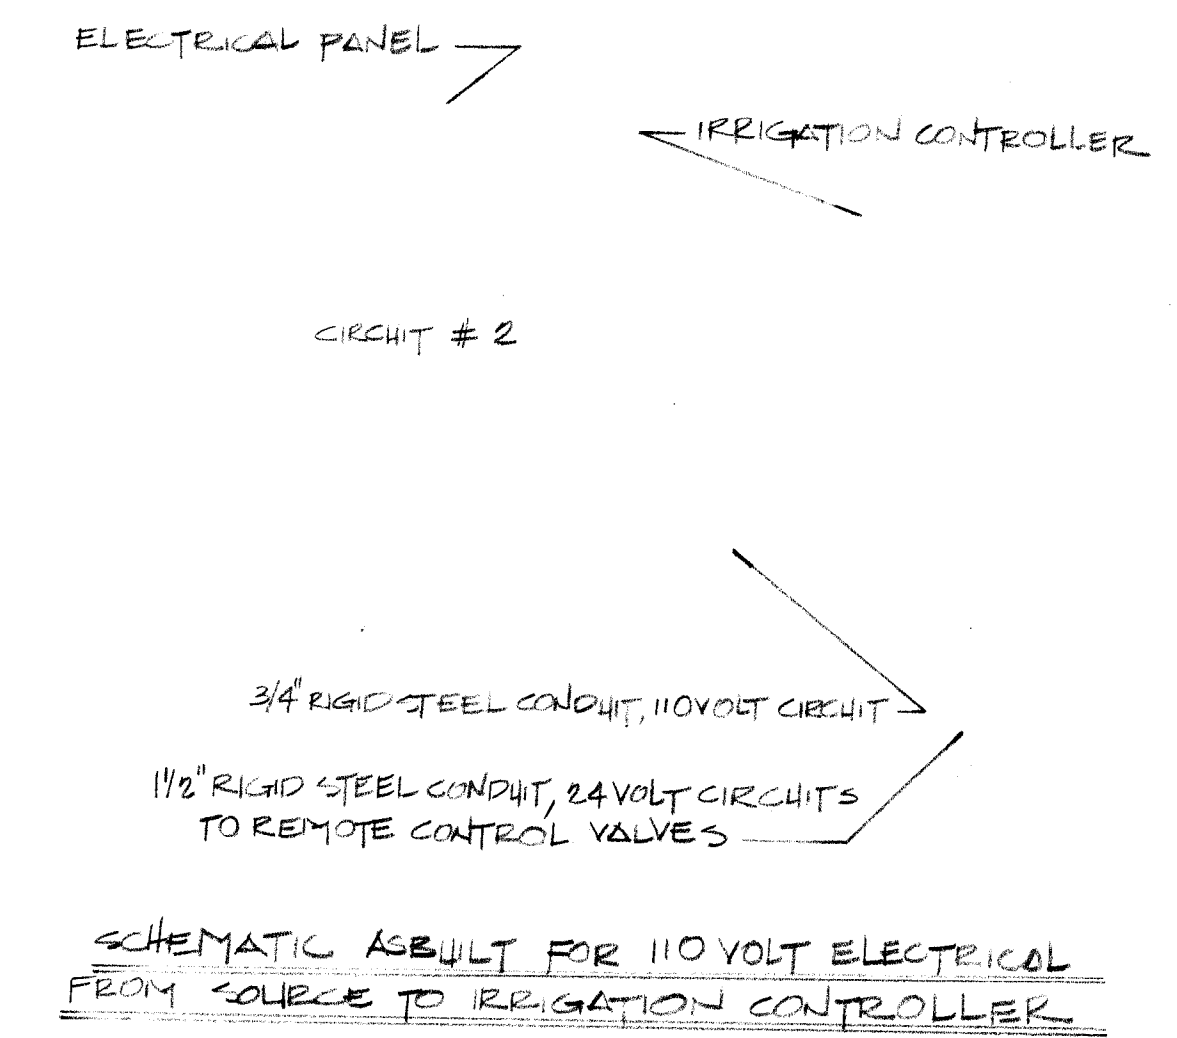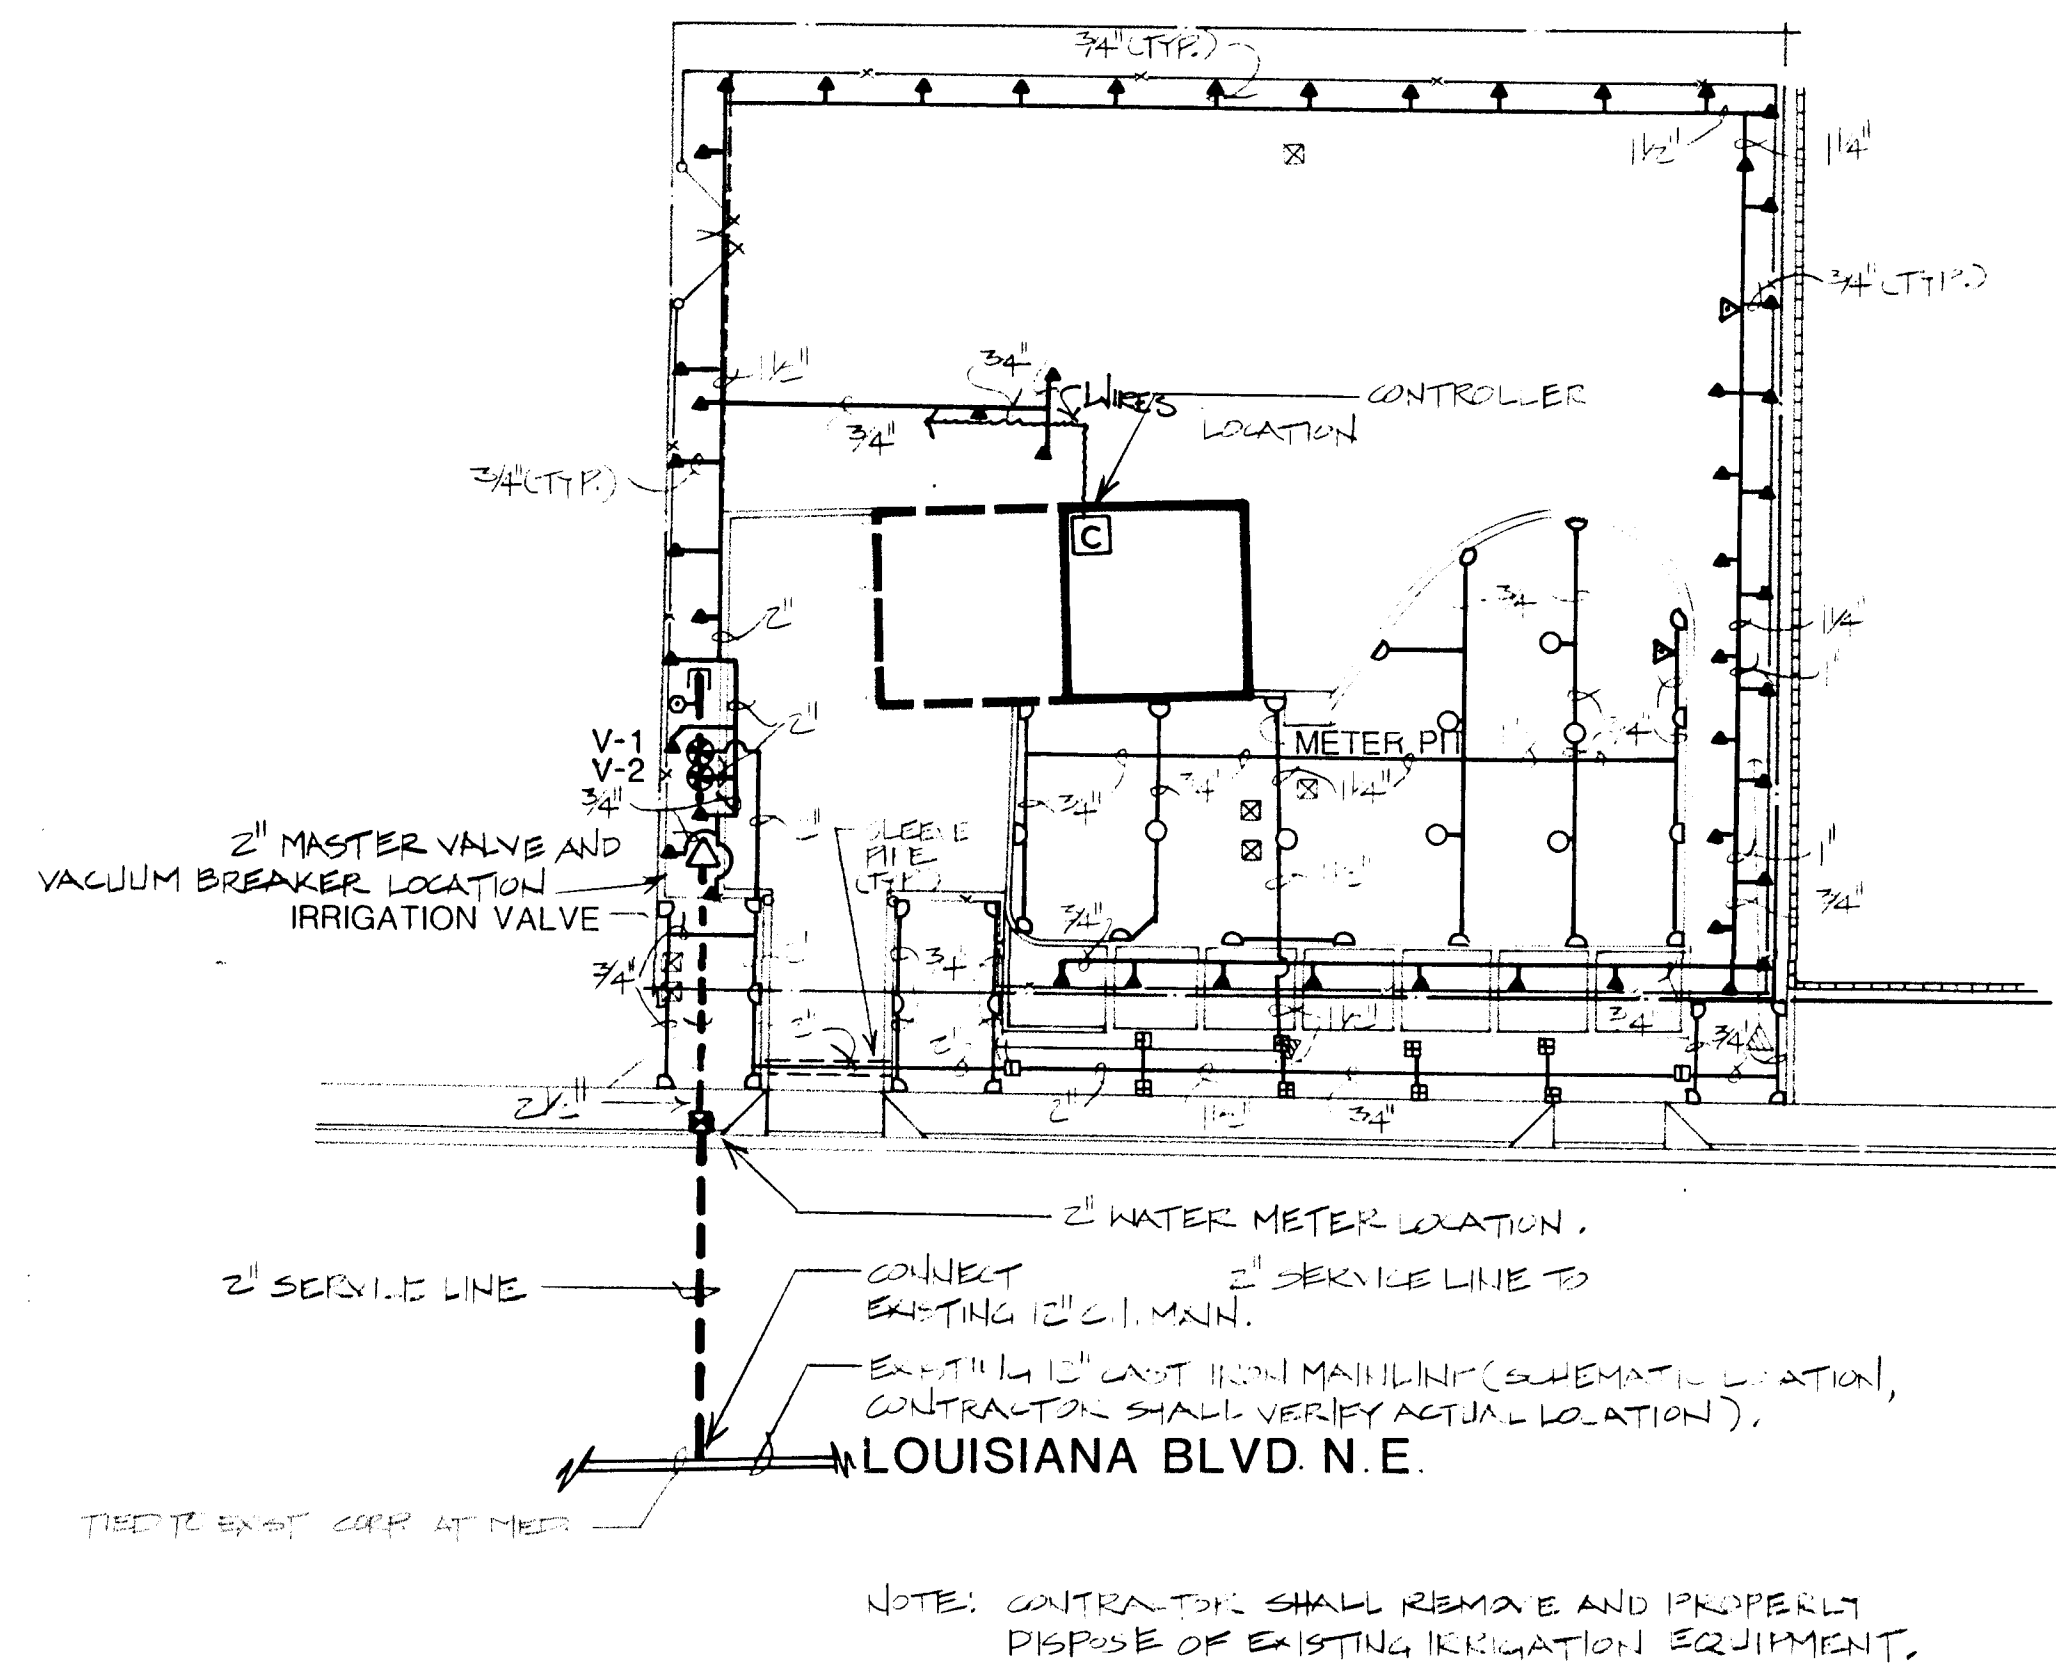

26 3097 5286

SCALE 1"=20'-0"

0 10 20 40

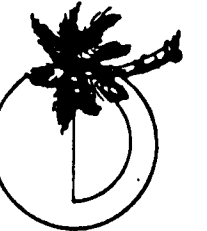

MORROW & COMPANY
LANDSCAPE ARCHITECTS
210 La Veta Drive NE
Albuquerque, New Mexico 87108
505-268-2266

NOVEMBER
1986


AS BUILT


LEYENDECKER WELL #2
3617 LOUISIANA BLVD. NE
IRRIGATION PLAN

LANDSCAPING IMPROVEMENTS FOR
WATER SYSTEM FACILITY SITES
WATER SYSTEMS DIVISION
CITY OF ALBUQUERQUE
ALBUQUERQUE, NEW MEXICO

SHEET

172

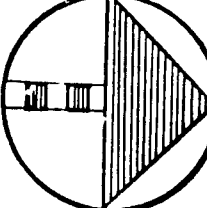


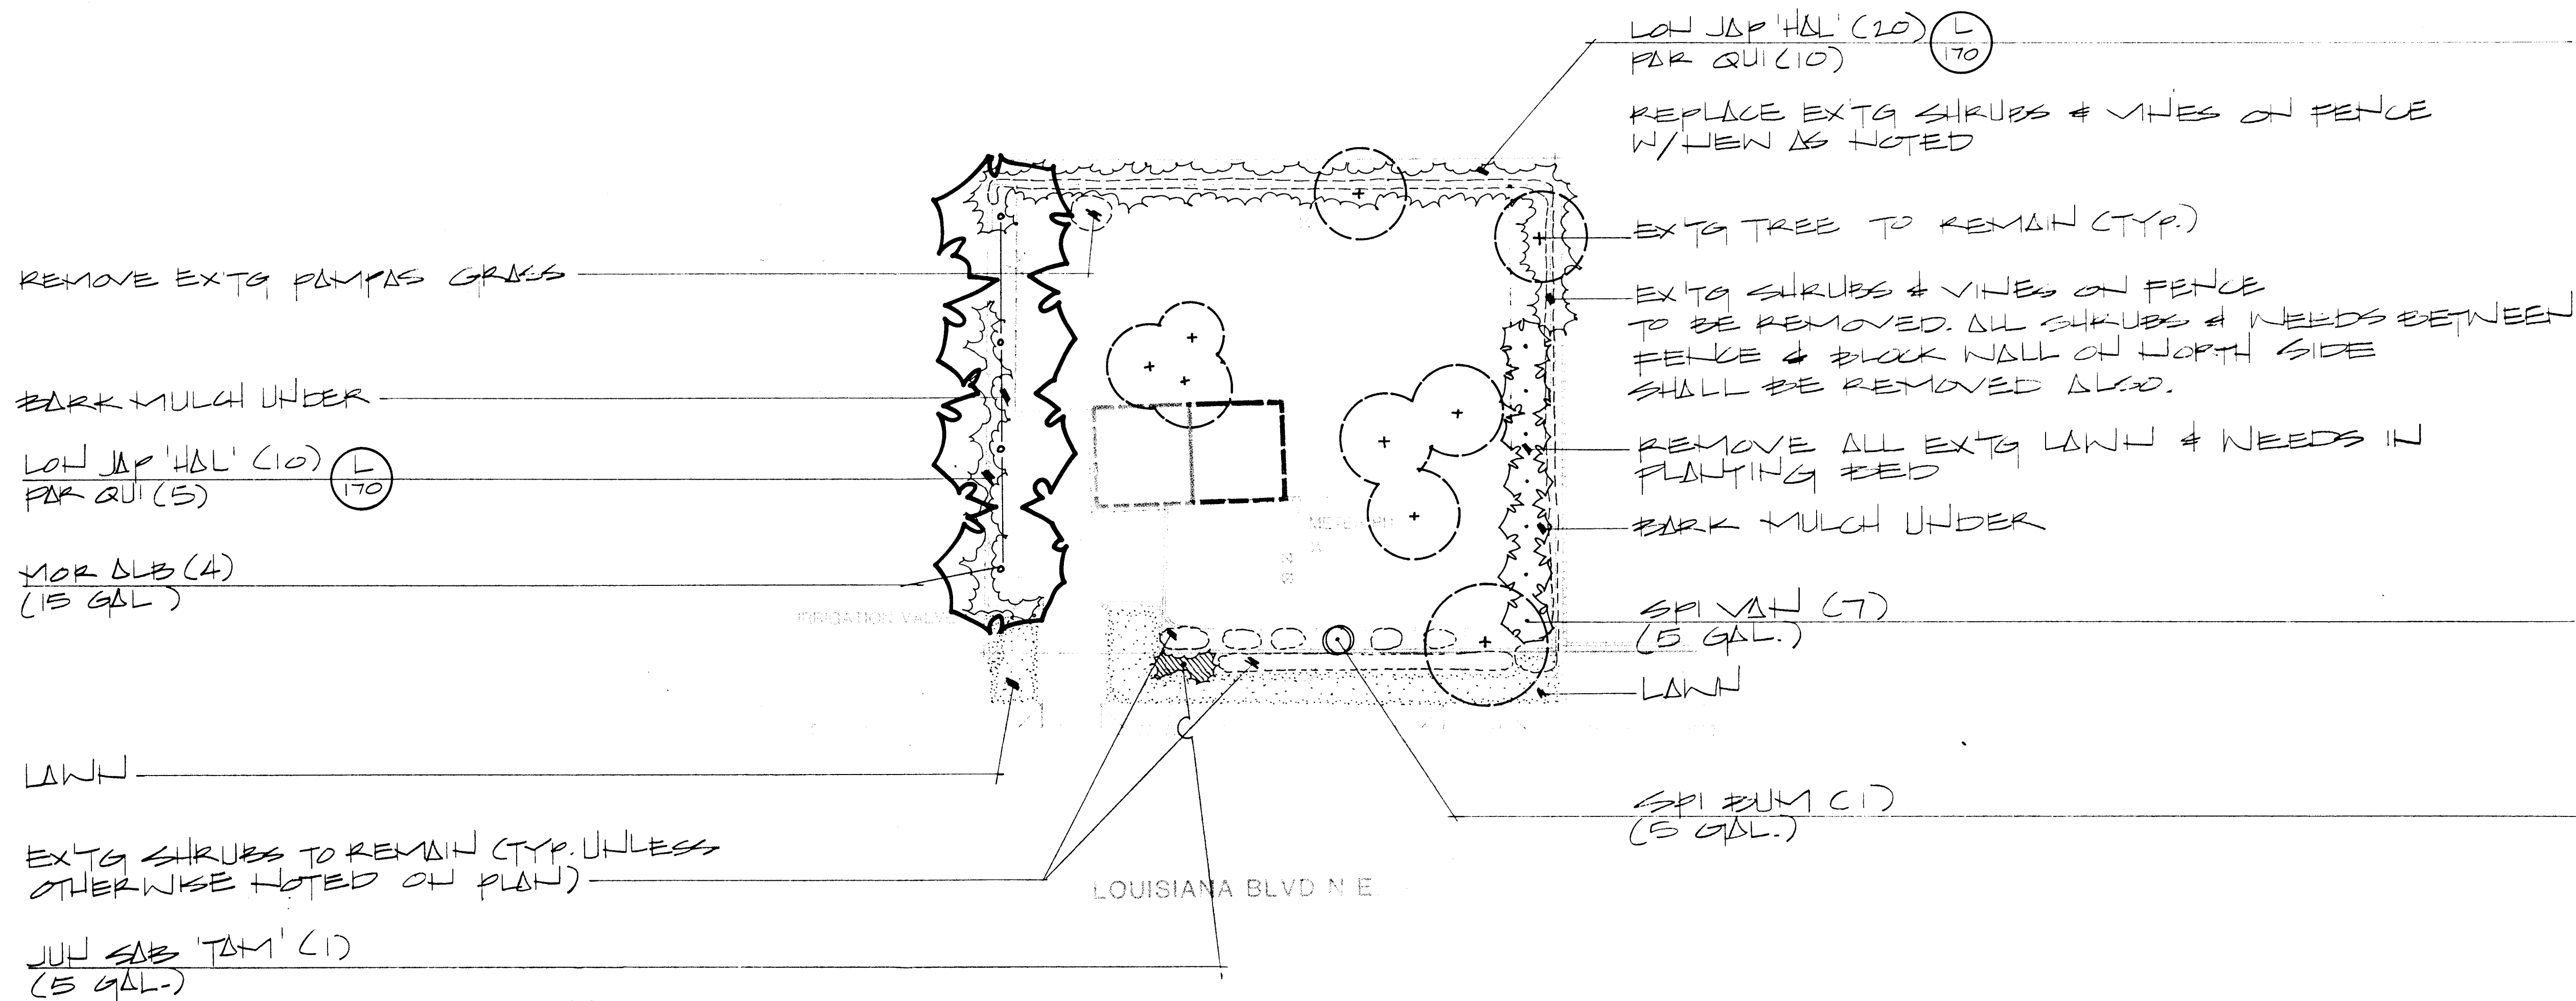

26 3097 5386

SCALE 1"=20'-0"

0 10 20 40

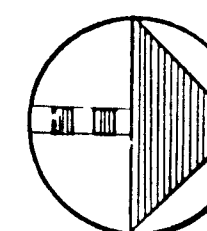

MORROW & COMPANY
LANDSCAPE ARCHITECTS
210 La Veta Drive NE
Albuquerque, New Mexico 87108
505-268-2266


NOVEMBER
1986

AS BUILT

LEYENDECKER WELL #2
3617 LOUISIANA BLVD. NE
PLANTING PLAN

LANDSCAPING IMPROVEMENTS FOR
WATER SYSTEM FACILITY SITES
WATER SYSTEMS DIVISION
CITY OF ALBUQUERQUE
ALBUQUERQUE, NEW MEXICO


SHEET
97
172

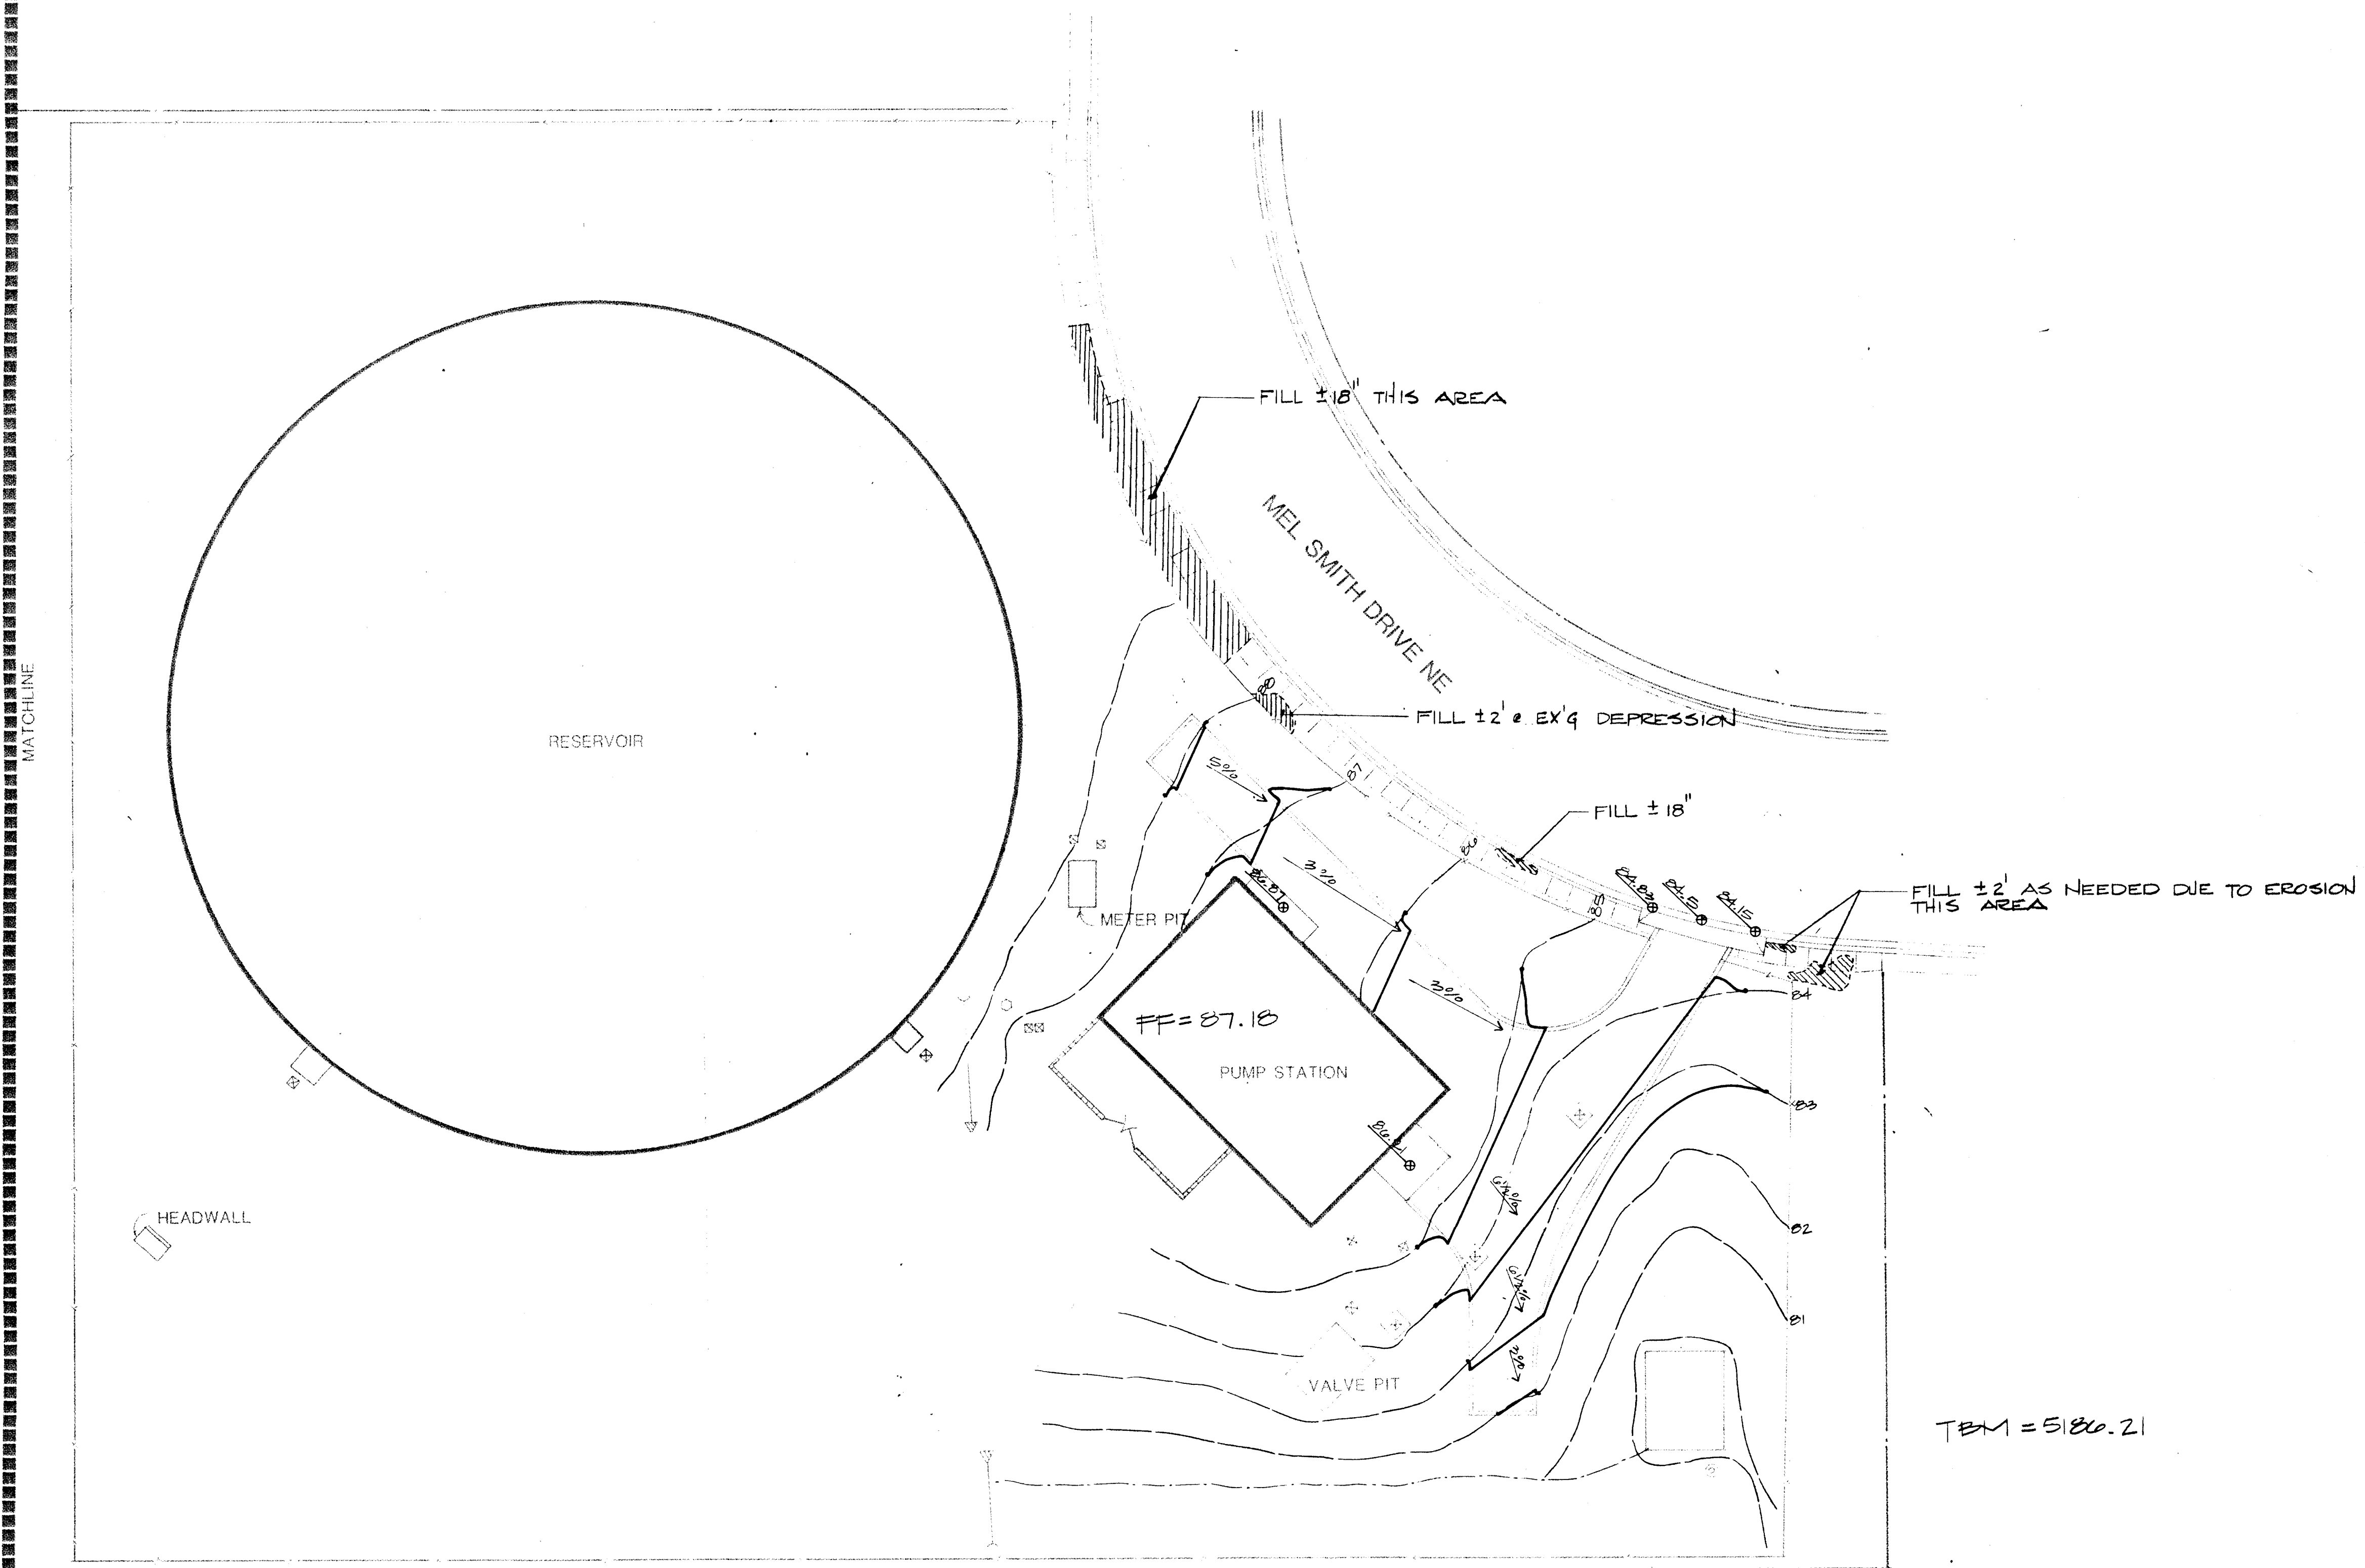

26 30 97 5486

SCALE 1"=20'-0"

0 10 20 40

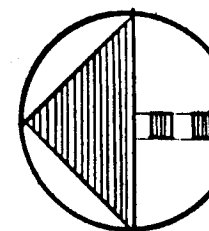

LANDSCAPING IMPROVEMENTS FOR
WATER SYSTEM FACILITY SITES
WATER SYSTEMS DIVISION
CITY OF ALBUQUERQUE
ALBUQUERQUE, NEW MEXICO


SHEET
88
172

LINDA VISTA RESERVOIR & PUMP STATION
14009 MEL SMITH ROAD NE
GRADING PLAN


AS BUILT

NOVEMBER
1986

MORROW & COMPANY
LANDSCAPE ARCHITECTS
210 La Veta Drive NE
Albuquerque, New Mexico 87108
505-268-2266


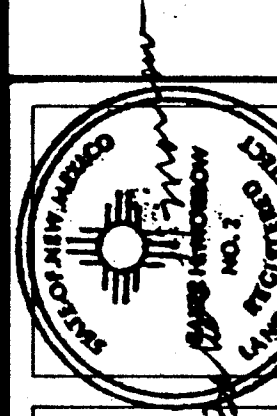


NOTE: NO CONSTRUCTION ON
NORTH SIDE OF MATCH LINE

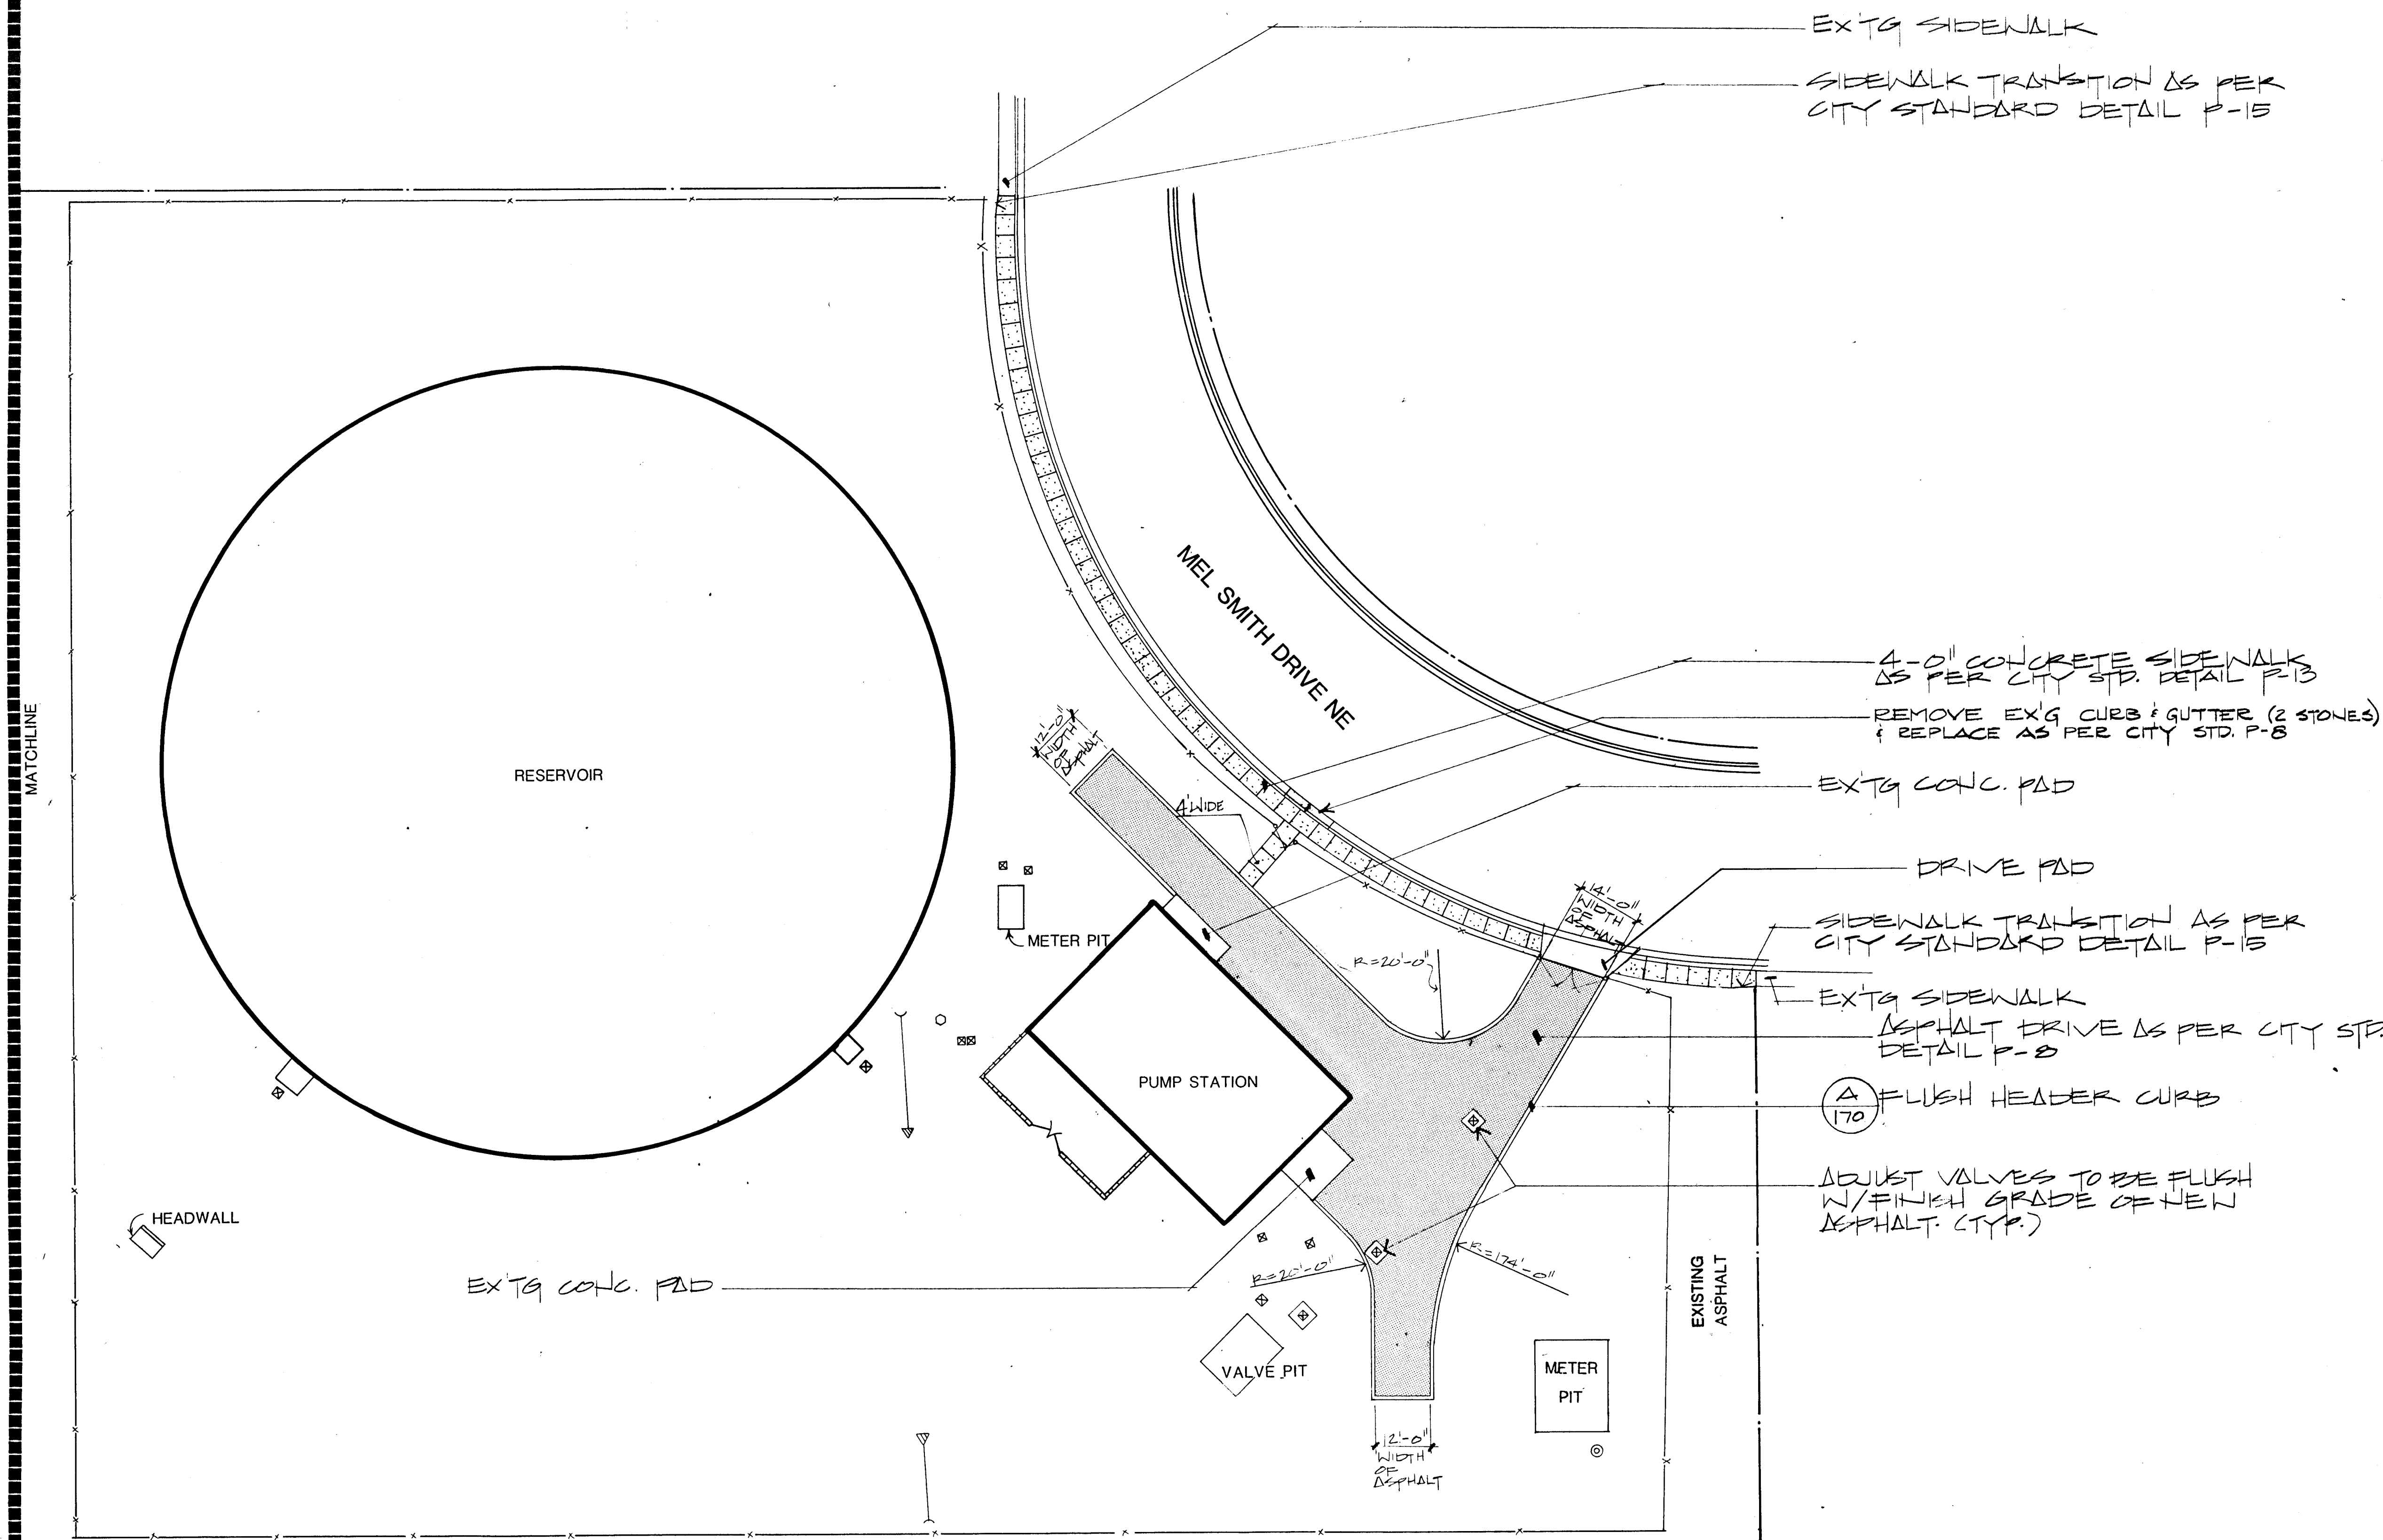

26 3097 5586

SCALE 1"=20'-0"
0 10 20 40

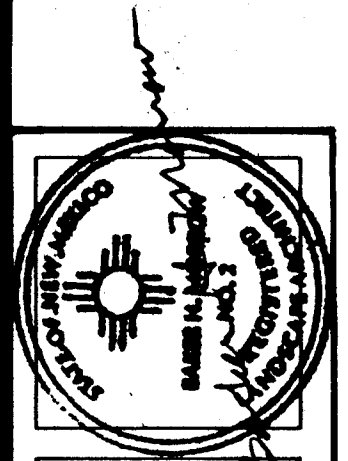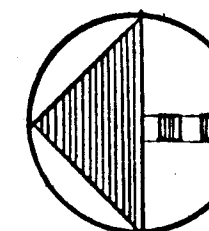

MORROW & COMPANY
LANDSCAPE ARCHITECTS
210 La Veta Drive NE
Albuquerque, New Mexico 87108
505-268-2266




NOVEMBER
1986

LINDA VISTA RESERVOIR & PUMP STATION
14009 MEL SMITH ROAD NE
AS BUILT
CONSTRUCTION PLAN

LANDSCAPING IMPROVEMENTS FOR
WATER SYSTEM FACILITY SITES
WATER SYSTEMS DIVISION
CITY OF ALBUQUERQUE
ALBUQUERQUE, NEW MEXICO

SHEET
87
OF
172

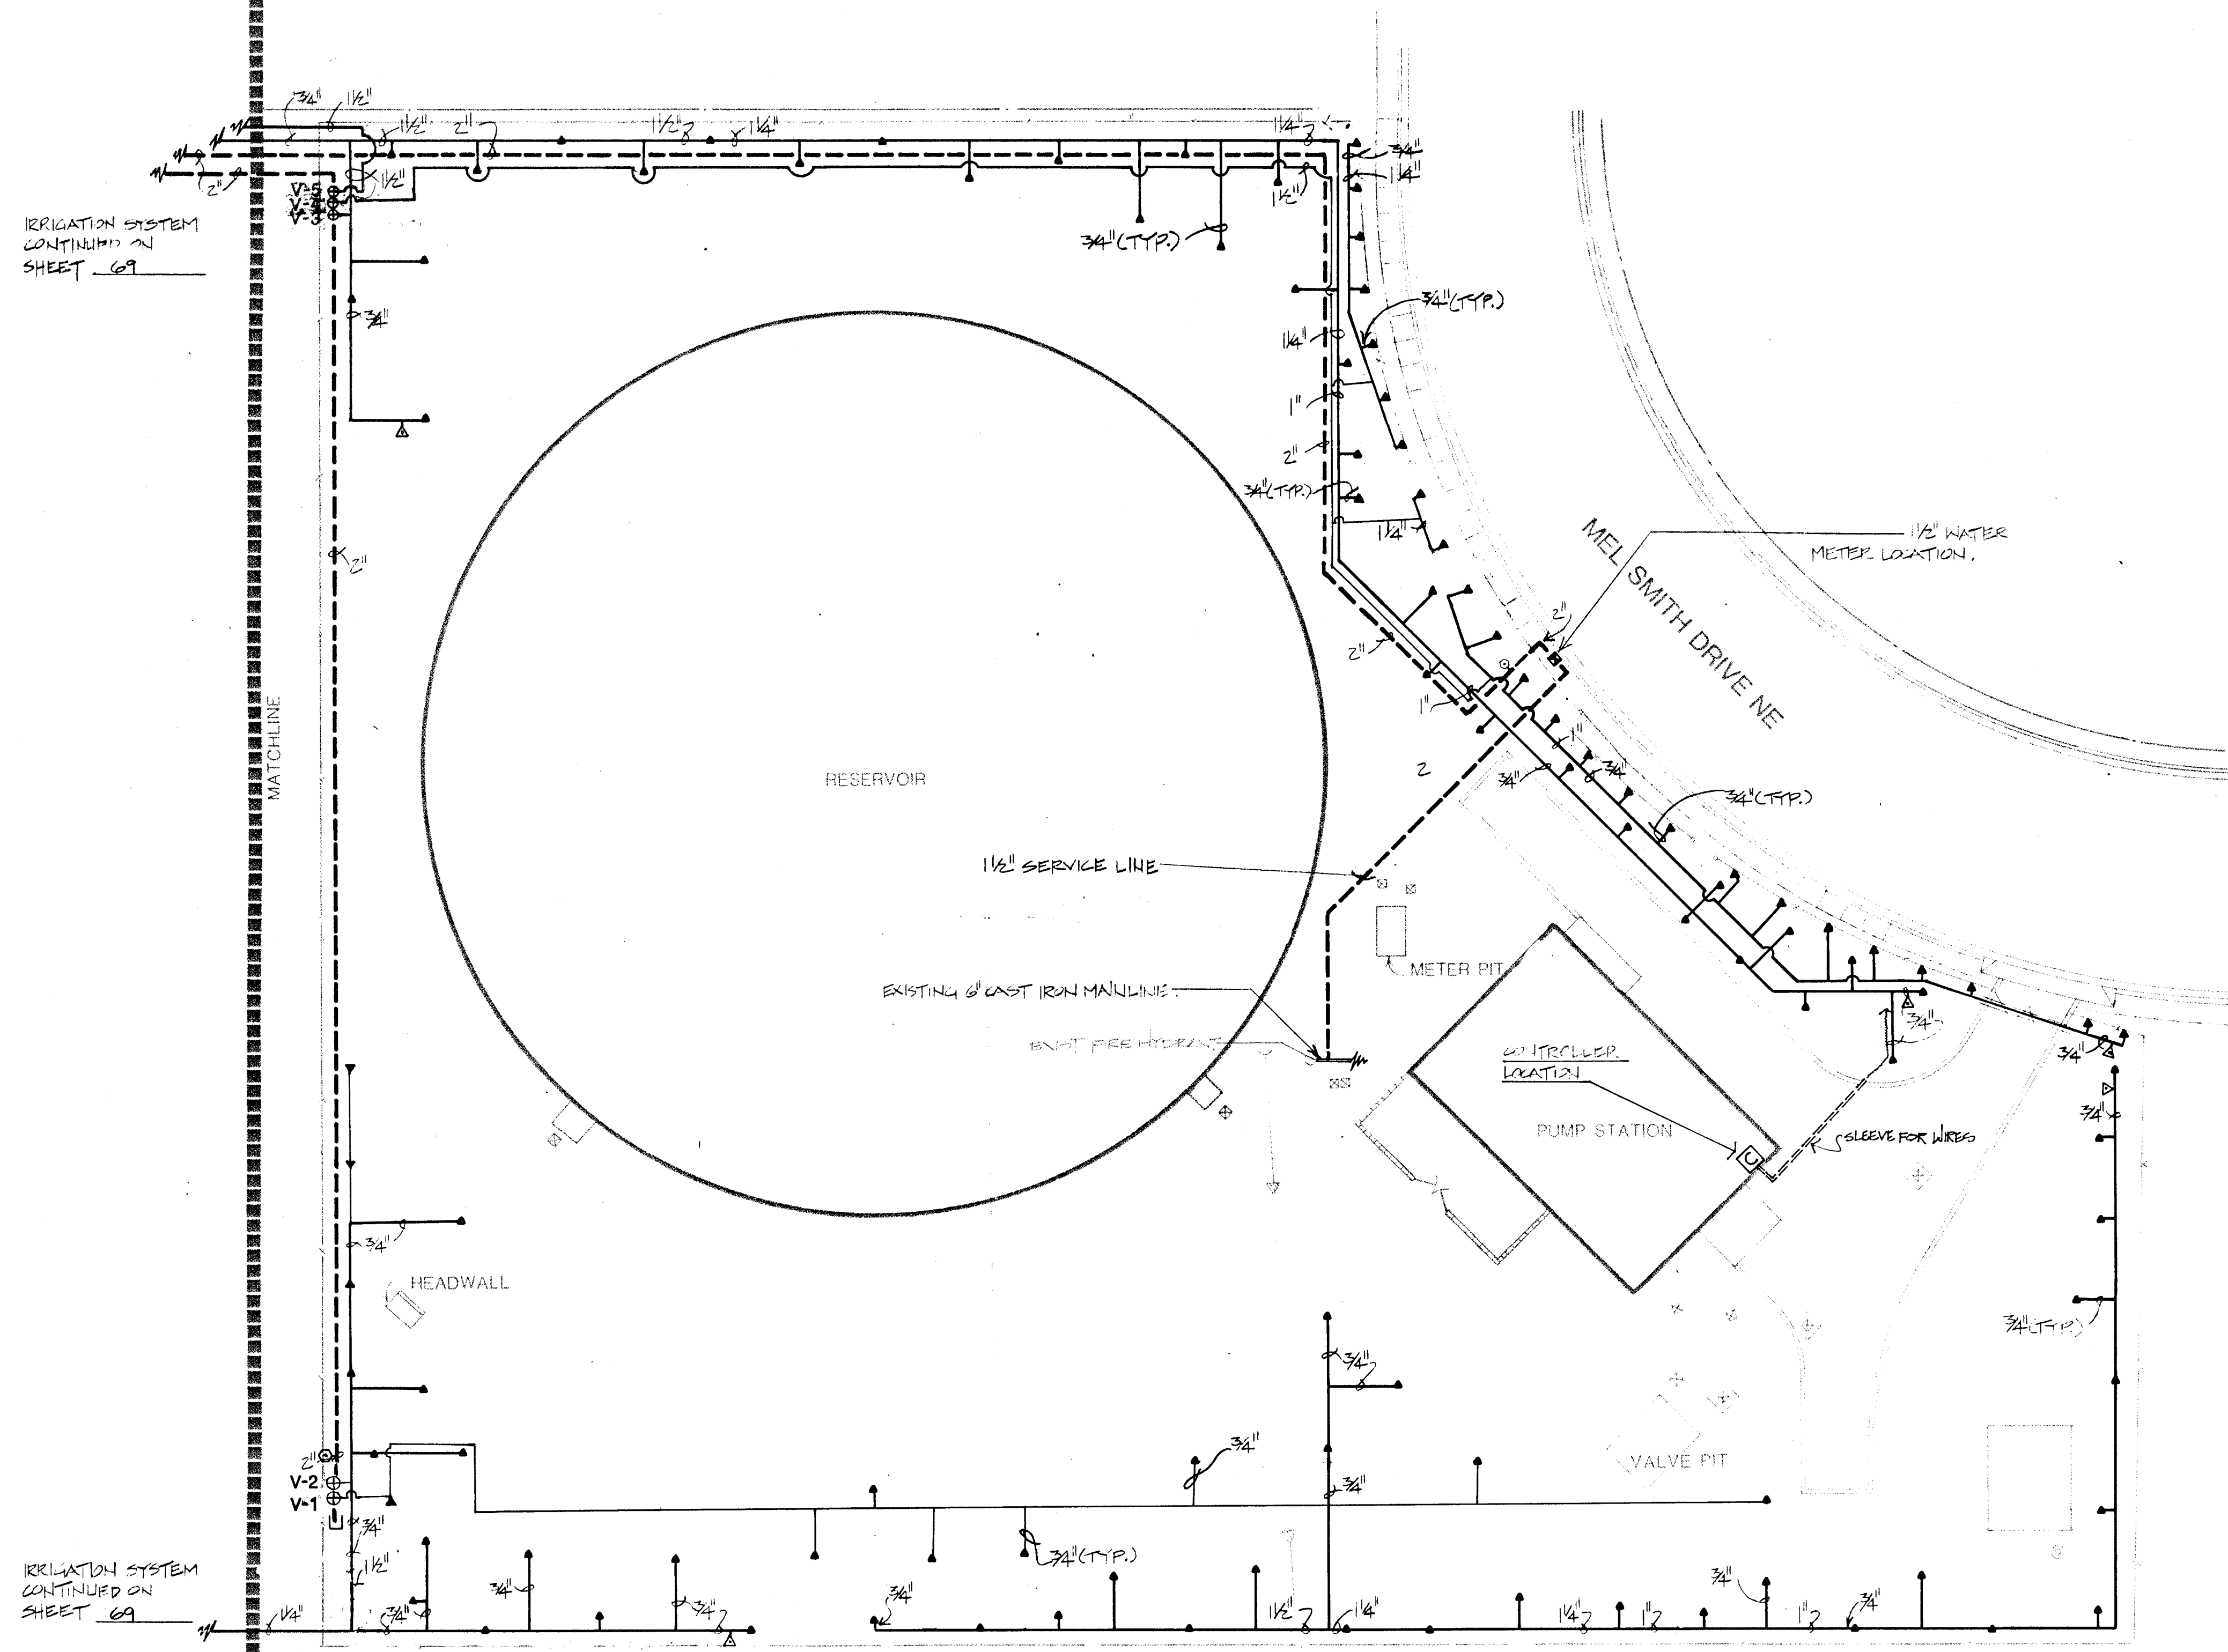

IRRIGATION SYSTEM
CONTINUED ON
SHEET 69

IRRIGATION SYSTEM
CONTINUED ON
SHEET 69

ELECTRICAL PANEL - L

IRRIGATION CONTROLLER

CIRCUIT # 8

3/4" RIGID STEEL CONDUIT, 110 VOLT CIRCUIT

1 1/2" RIGID STEEL CONDUIT, 24 VOLT CIRCUITS
TO REMOTE CONTROL VALVES

SCHEMATIC AS-BUILT FOR 110 VOLT ELECTRICAL
FROM SOURCE TO IRRIGATION CONTROLLER

26 3097 5686

SCALE 1"=20'-0"

0 10 20 40


MORROW & COMPANY
LANDSCAPE ARCHITECTS
210 La Veta Drive NE
Albuquerque, New Mexico 87108
505-268-2266

NOVEMBER
1986

LINDA VISTA RESERVOIR & PUMP STATION
14009 MEL SMITH ROAD NE
IRRIGATION PLAN

LANDSCAPING IMPROVEMENTS FOR
WATER SYSTEM FACILITY SITES
WATER SYSTEMS DIVISION
CITY OF ALBUQUERQUE
ALBUQUERQUE, NEW MEXICO

SHEET
68
OF
172

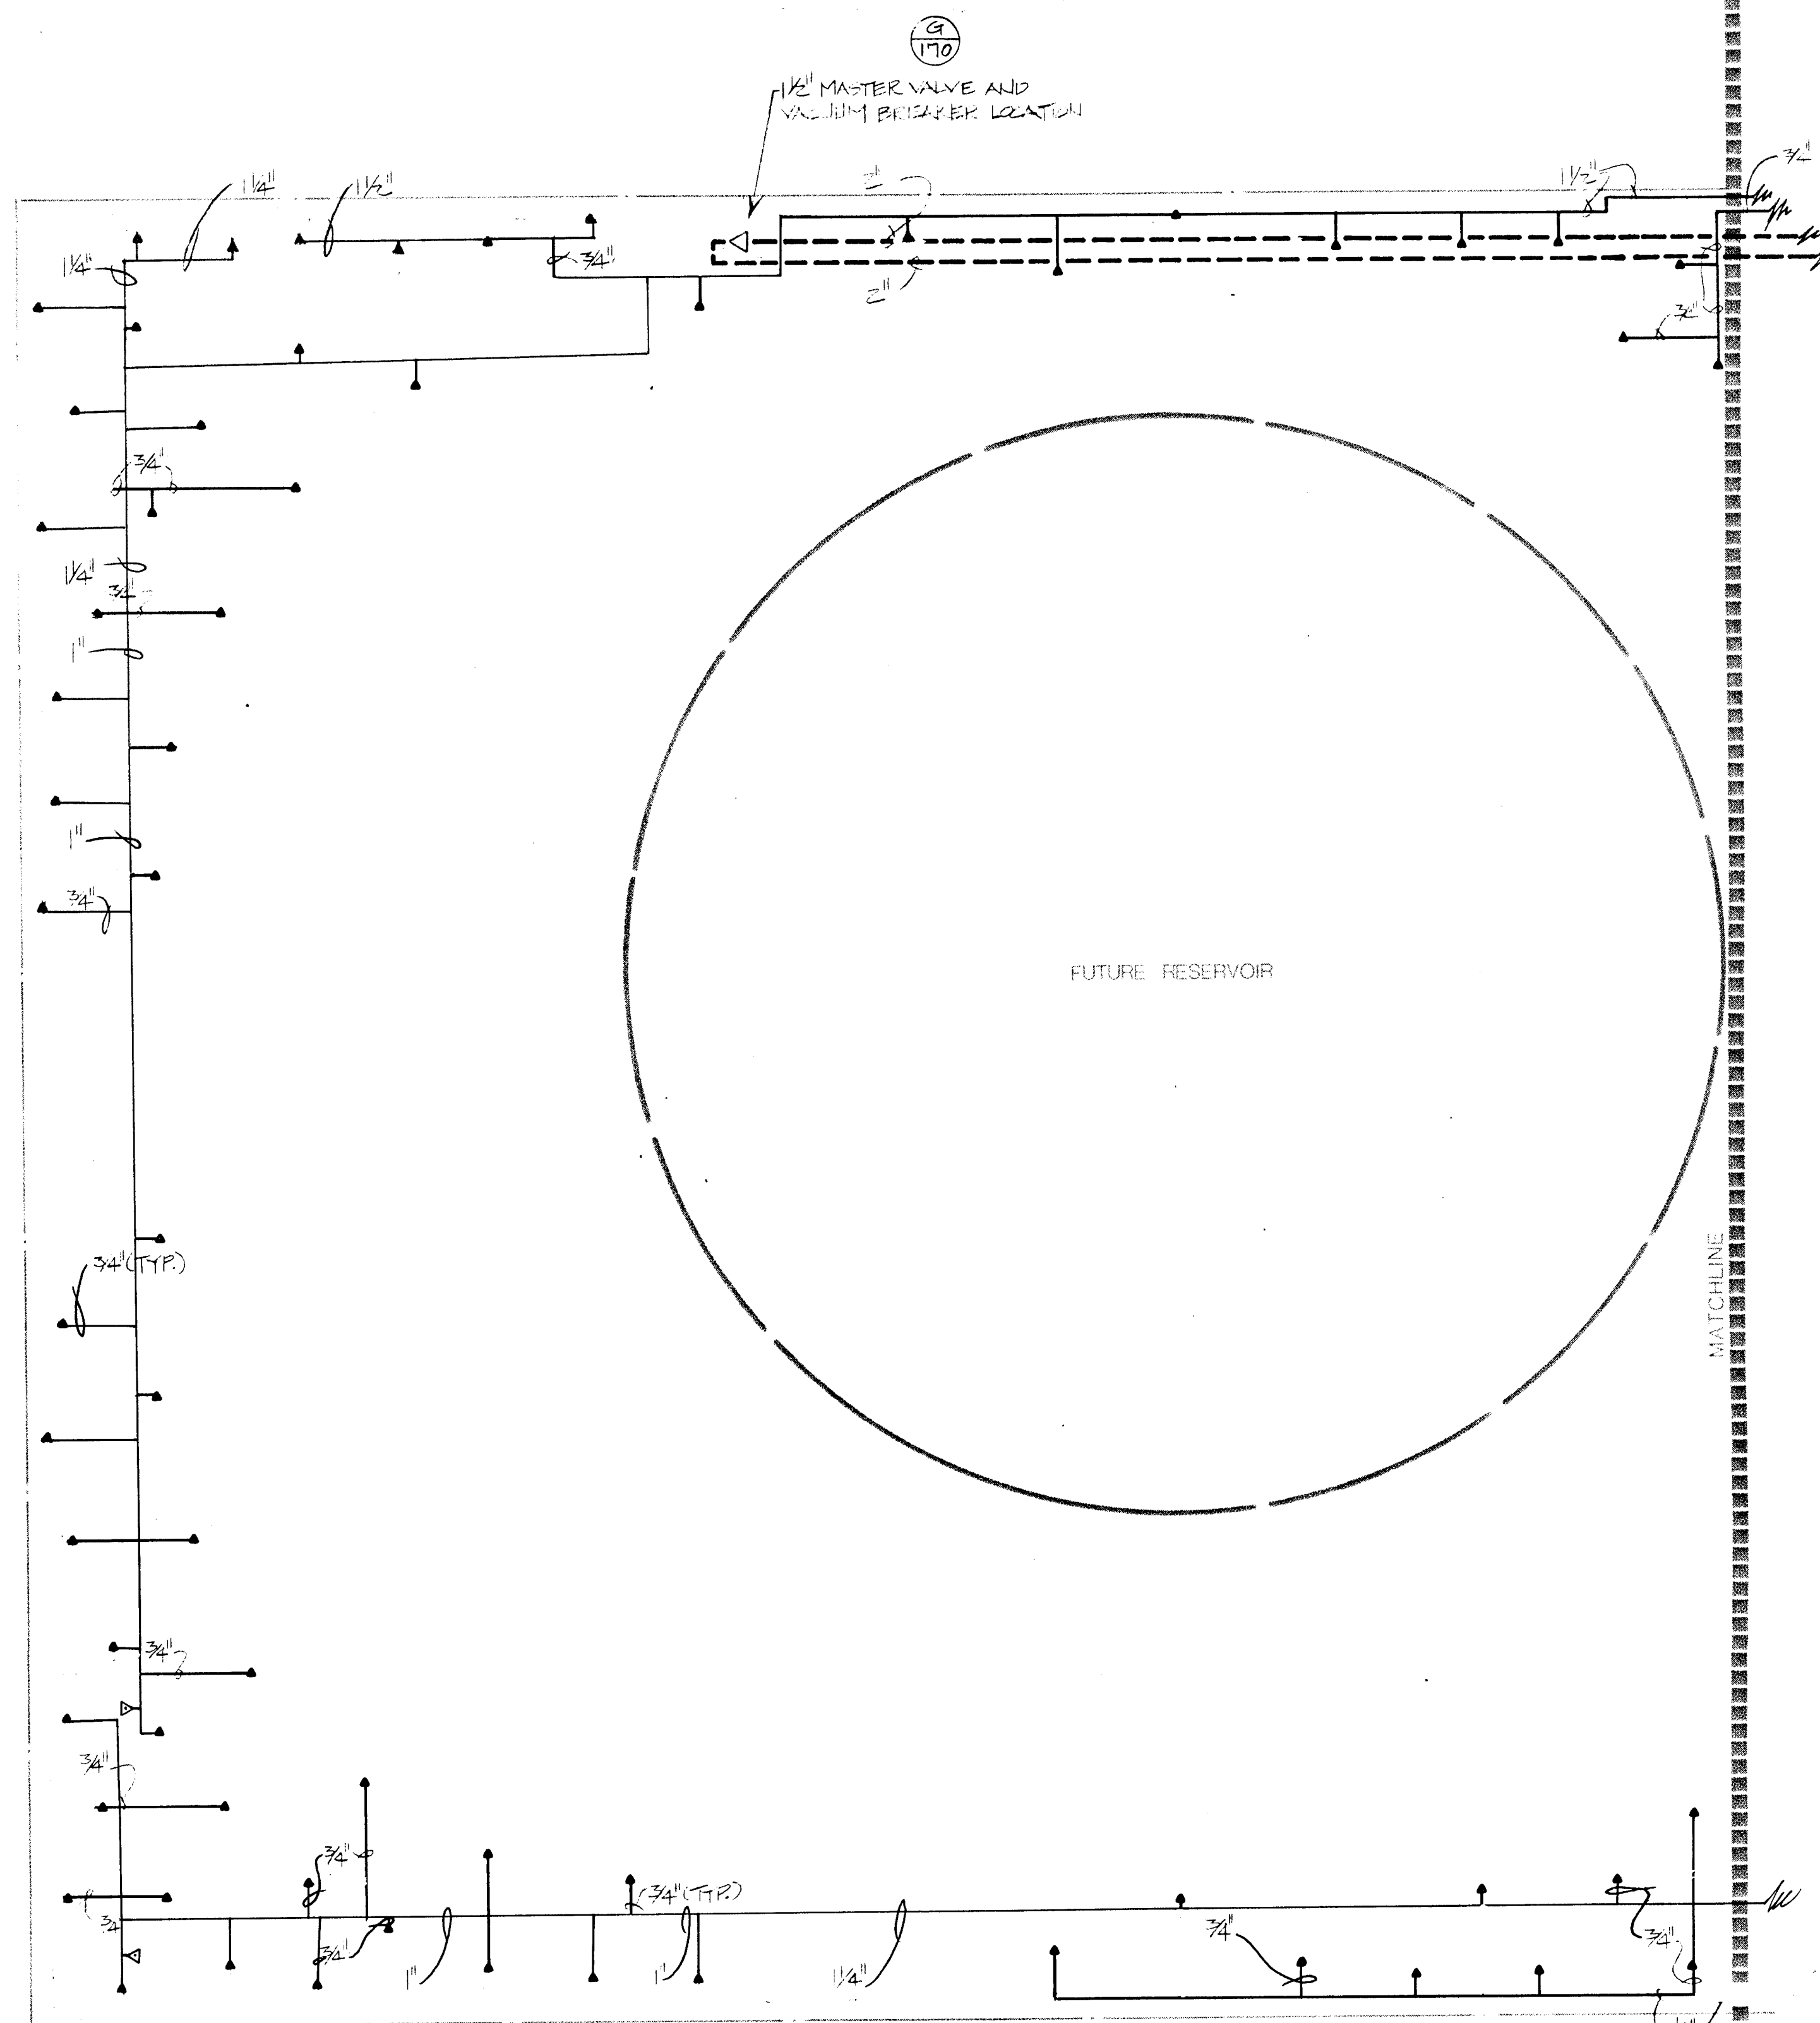


IRRIGATION SYSTEM
CONTINUED ON
SHEET 6B

IRRIGATION SYSTEM
CONTINUED ON
SHEET 6B

SCALE 1"=20'-0"

26 3097 5786

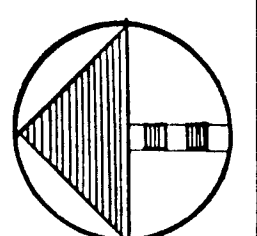



LANDSCAPING IMPROVEMENTS FOR
WATER SYSTEM FACILITY SITES
WATER SYSTEMS DIVISION
CITY OF ALBUQUERQUE
ALBUQUERQUE, NEW MEXICO


SHEET
6A
OF
172

LINDA VISTA RESERVOIR & PUMP STATION
14009 MEL SMITH ROAD NE
AS BUILT
IRRIGATION PLAN

NOVEMBER
1986



MORROW & COMPANY
LANDSCAPE ARCHITECTS
210 La Veta Drive NE
Albuquerque, New Mexico 87108
505-268-2266

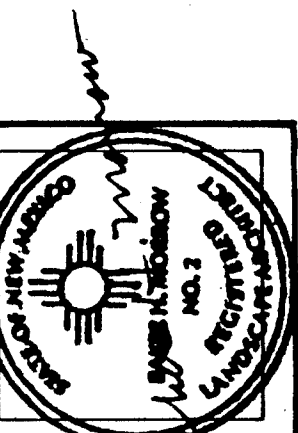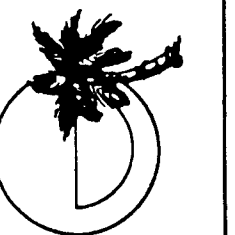

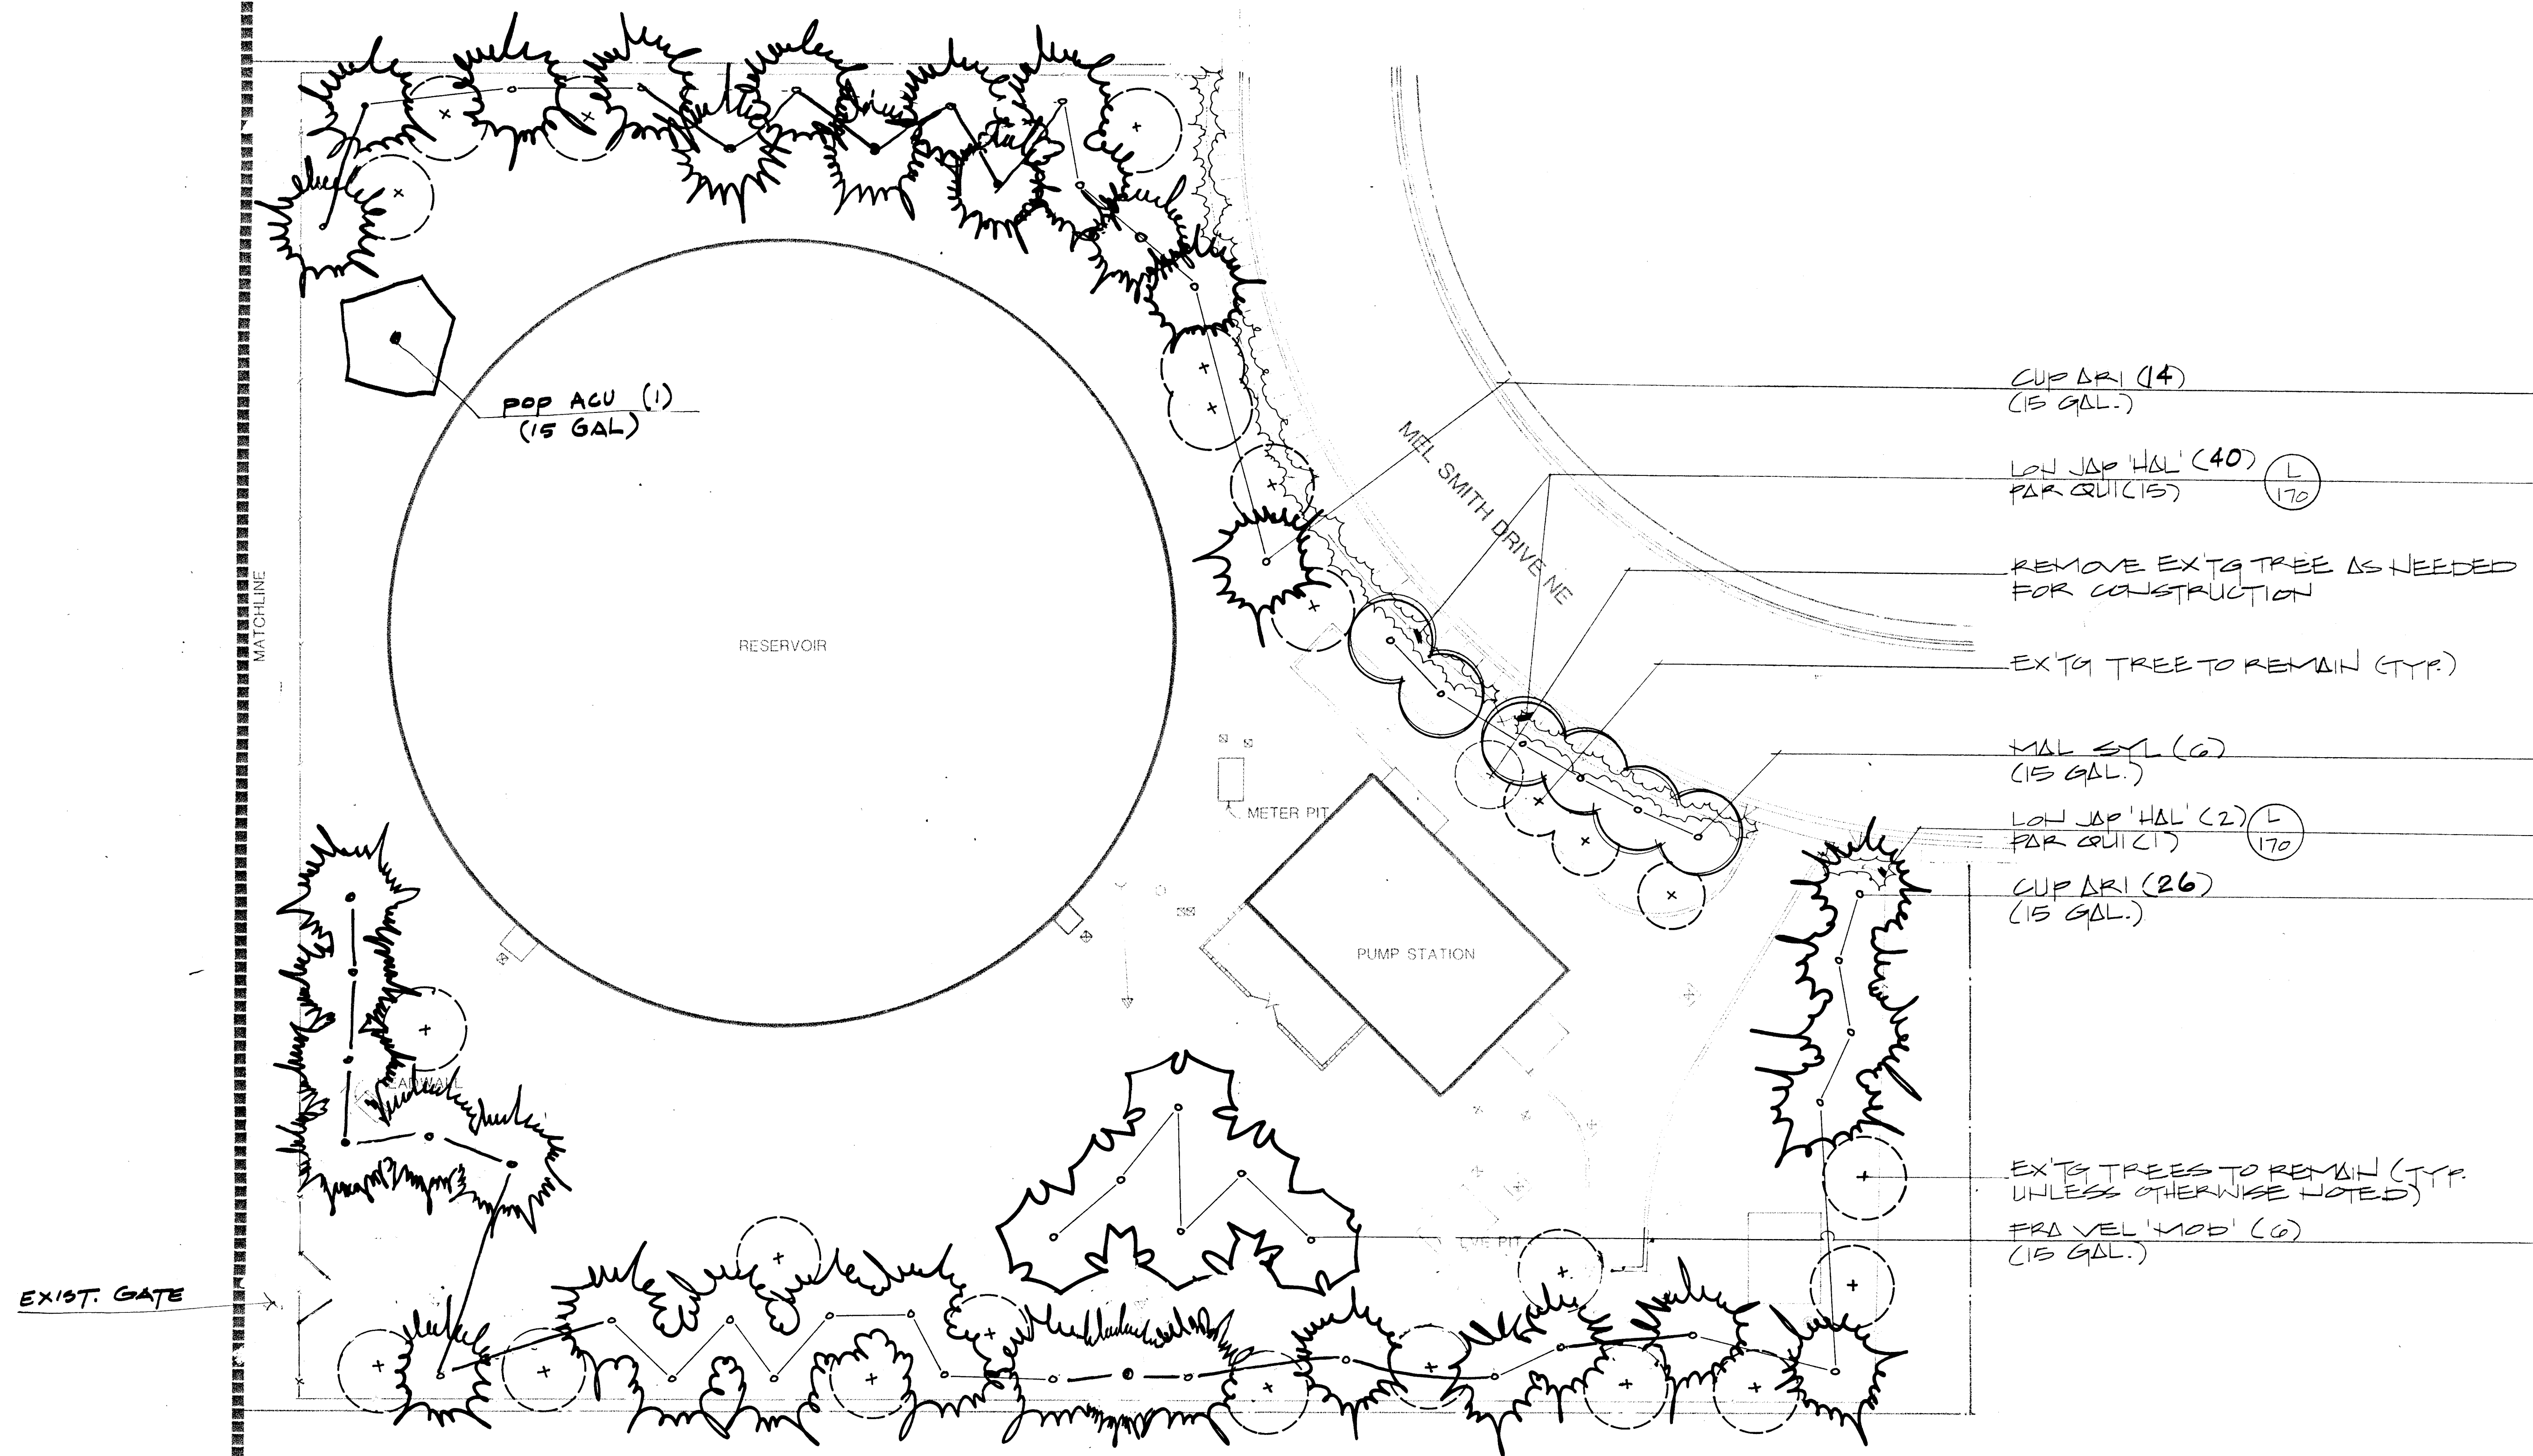


26 3097 5886

SCALE 1"=20'-0"
0 10 20 40

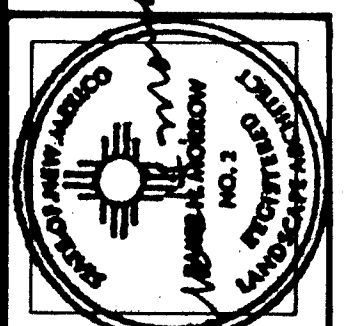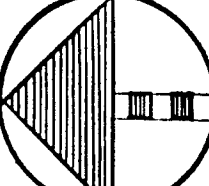

MORROW & COMPANY
LANDSCAPE ARCHITECTS
210 La Veta Drive NE
Albuquerque, New Mexico 87108
505-268-2266

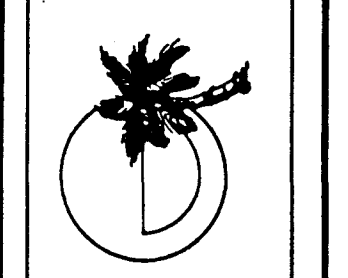


NOVEMBER
1986

LINDA VISTA RESERVOIR & PUMP STATION
14009 MEL SMITH ROAD NE
ALBUQUERQUE, NEW MEXICO
AS BUILT
PLANTING PLAN

LANDSCAPING IMPROVEMENTS FOR
WATER SYSTEM FACILITY SITES
WATER SYSTEMS DIVISION
CITY OF ALBUQUERQUE
ALBUQUERQUE, NEW MEXICO

SHEET
10
OF
172

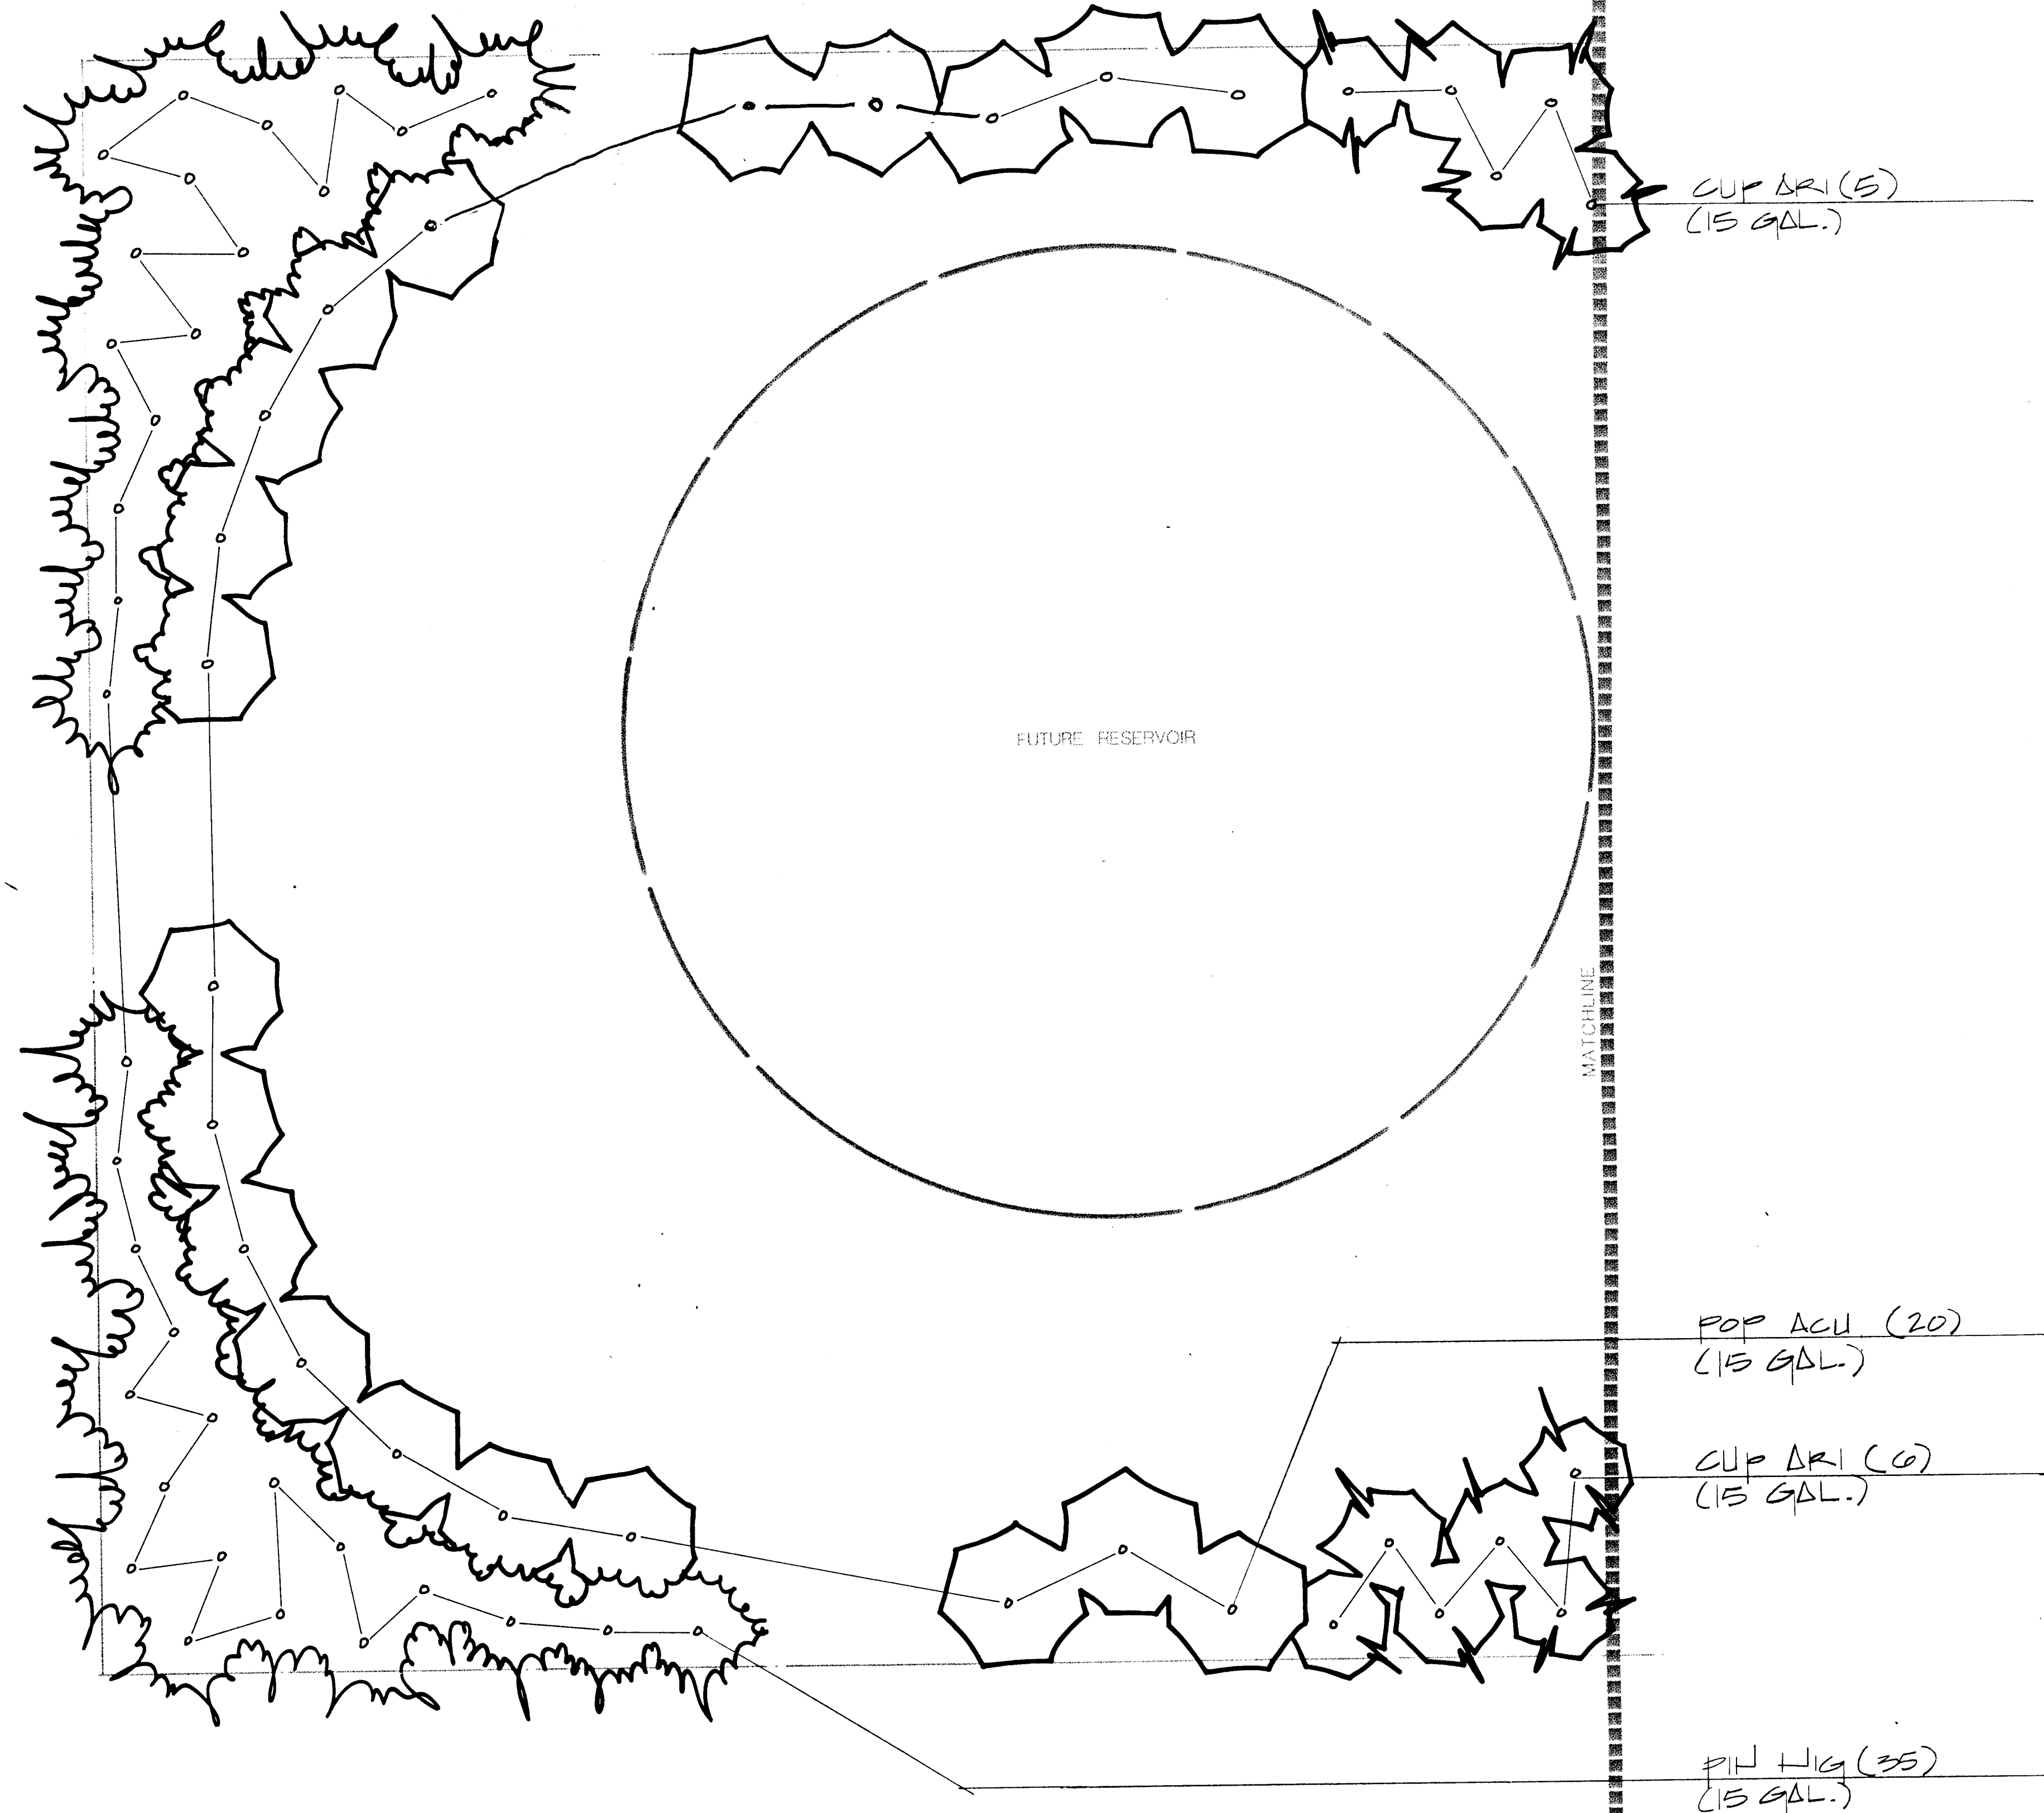


26 3097 5986

SCALE 1"=20'-0"



SHEET 172	LANDSCAPING IMPROVEMENTS FOR WATER SYSTEM FACILITY SITES WATER SYSTEMS DIVISION CITY OF ALBUQUERQUE ALBUQUERQUE, NEW MEXICO	LINDA VISTA RESERVOIR & PUMP STATION 14009 MEL SMITH ROAD NE PLANTING PLAN AS BUILT NOVEMBER 1986	MORROW & COMPANY LANDSCAPE ARCHITECTS 210 La Veta Drive NE Albuquerque, New Mexico 87108 505-268-2266
-----------------------------	---	---	---

NOTE:
NO CONSTRUCTION IMPROVEMENTS
OR GRADING CHANGES ON EAST
SIDE OF MATCH LINE.

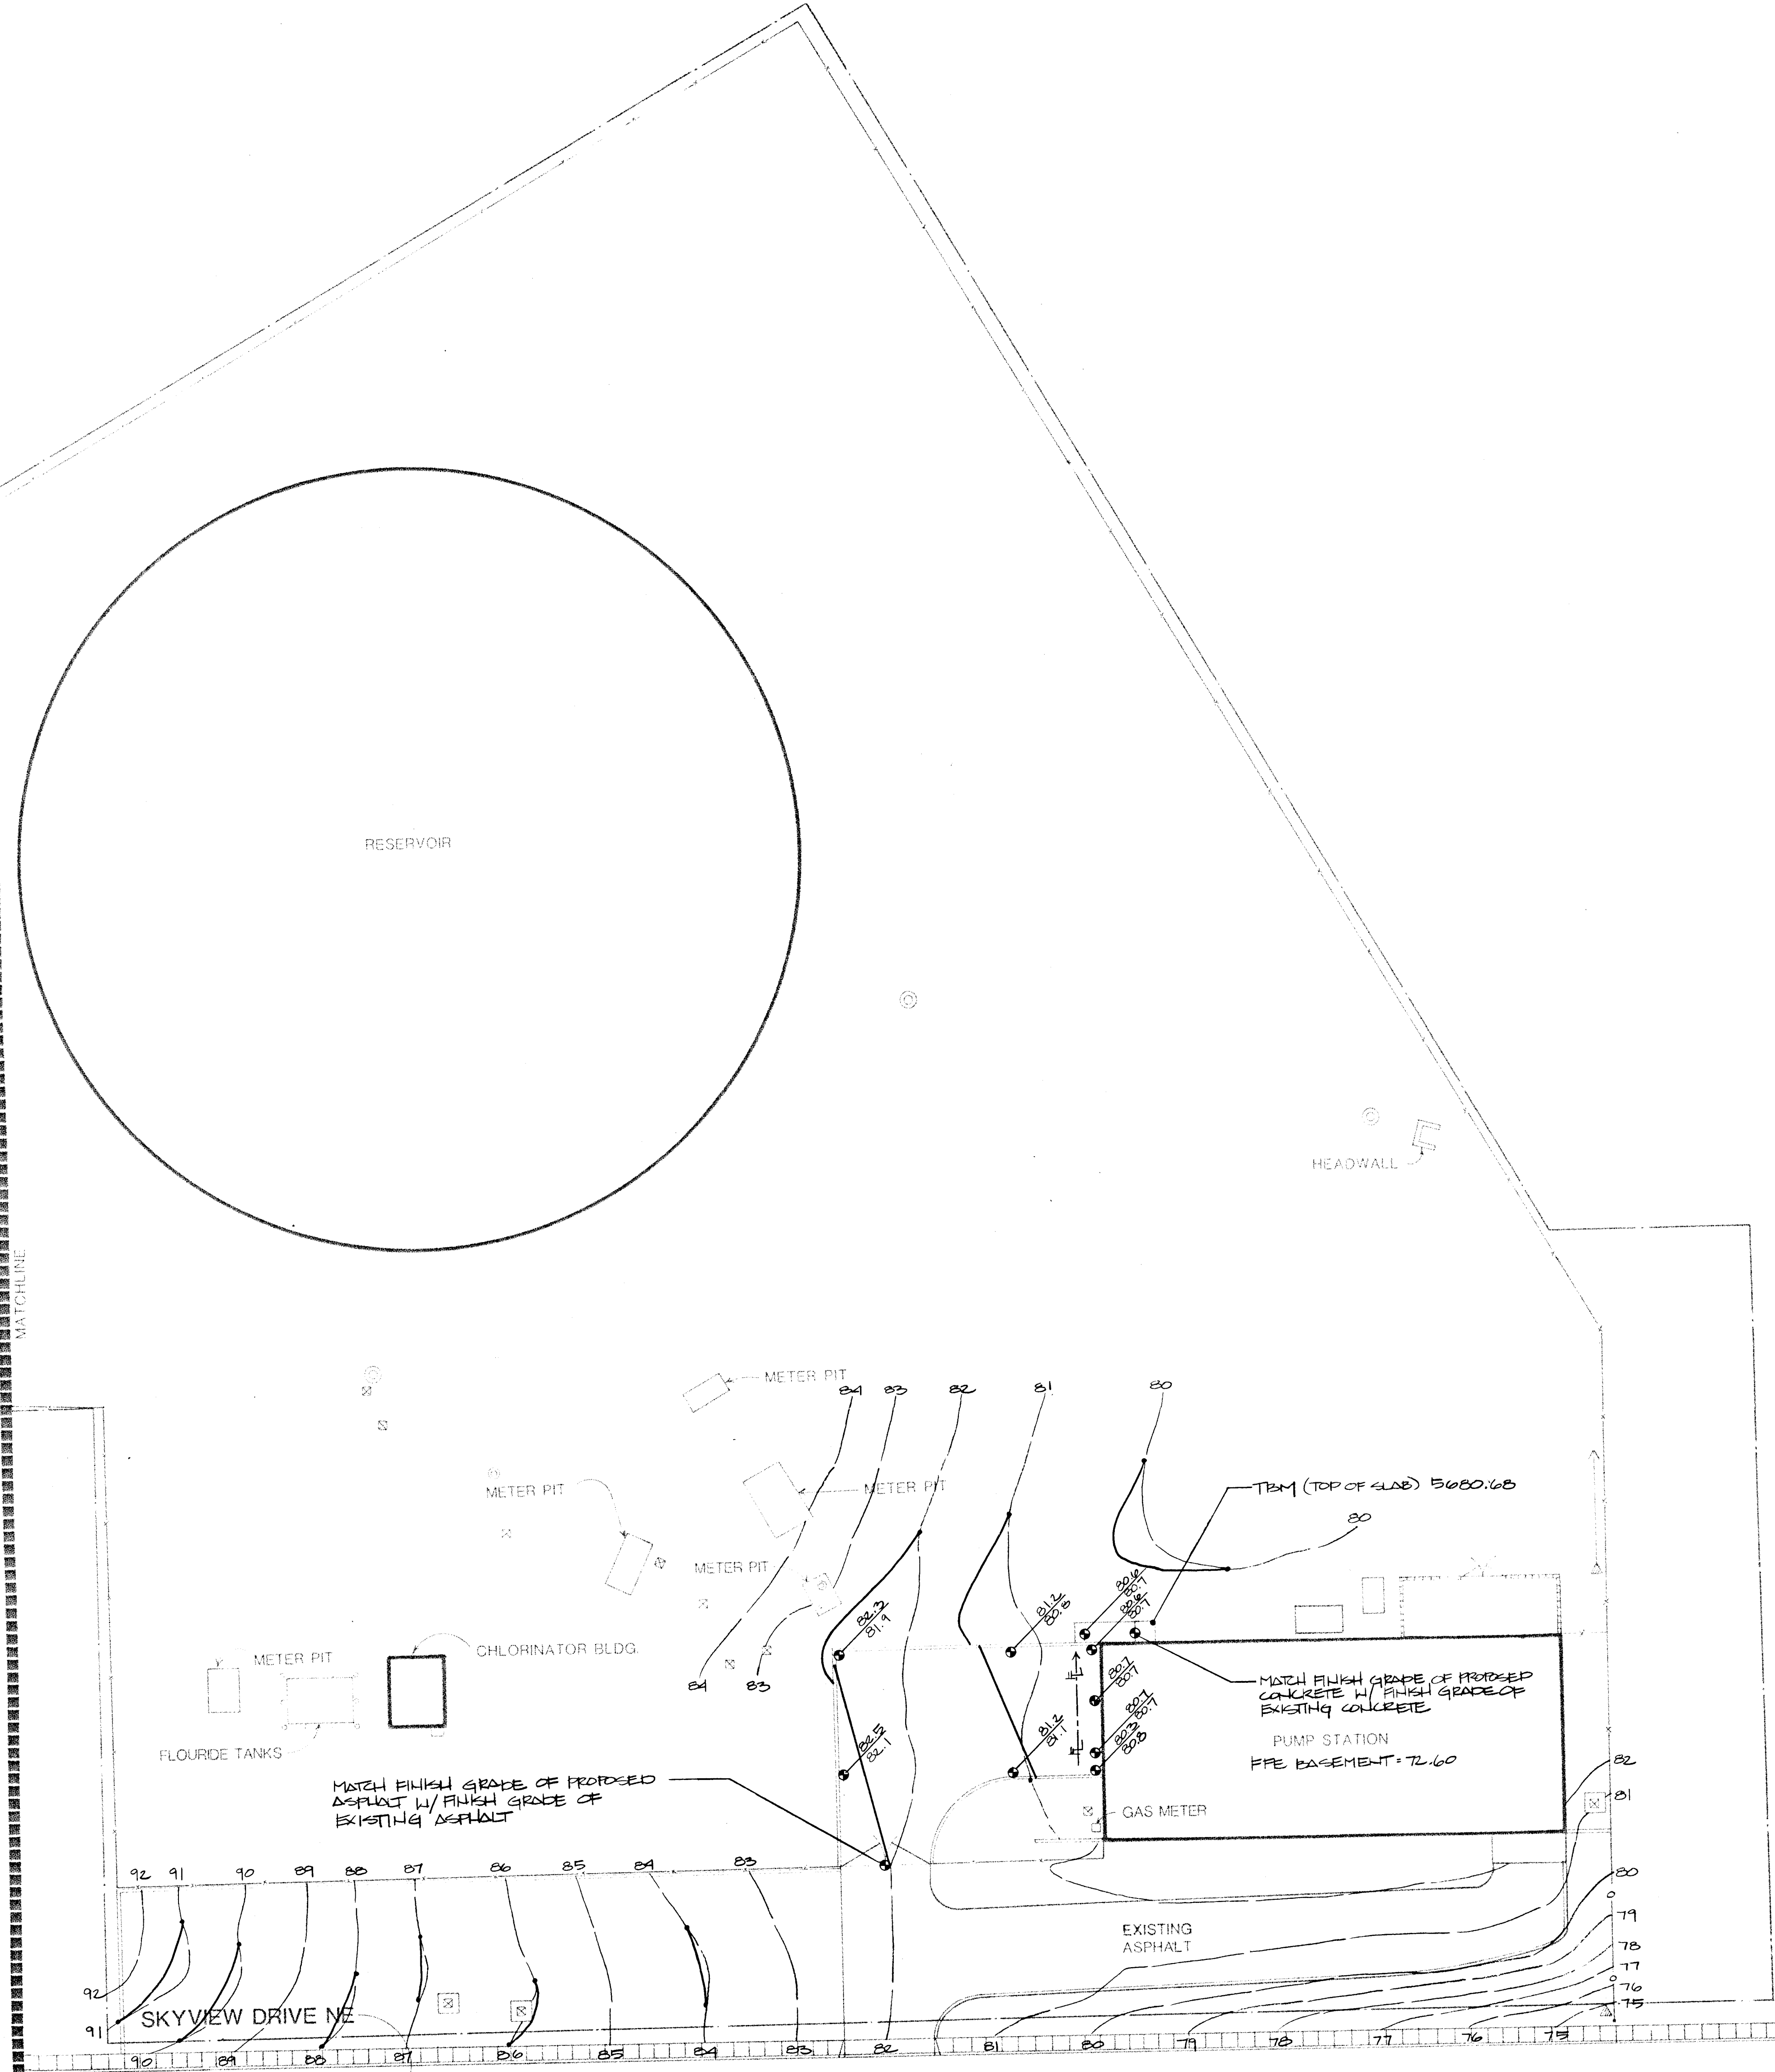

26.3097.6086

SCALE 1"=20'-0"

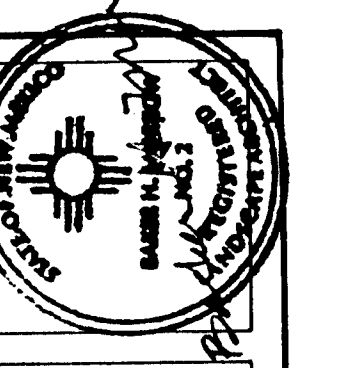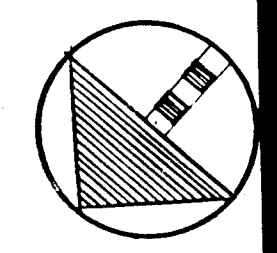

MORROW & COMPANY
LANDSCAPE ARCHITECTS
210 La Veta Drive NE
Albuquerque, New Mexico 87108
505-268-2266



NOVEMBER
1986


LOMAS RESERVOIR #1 & #2 & PUMP STATION
13200 SKYVIEW DRIVE NE
GRADING PLAN

AS BUILT

LANDSCAPING IMPROVEMENTS FOR
WATER SYSTEM FACILITY SITES
WATER SYSTEMS DIVISION
CITY OF ALBUQUERQUE
ALBUQUERQUE, NEW MEXICO

SHEET
172
172

NOTE:
NO CONSTRUCTION IMPROVEMENTS
ON EAST SIDE OF MATCH LINE.

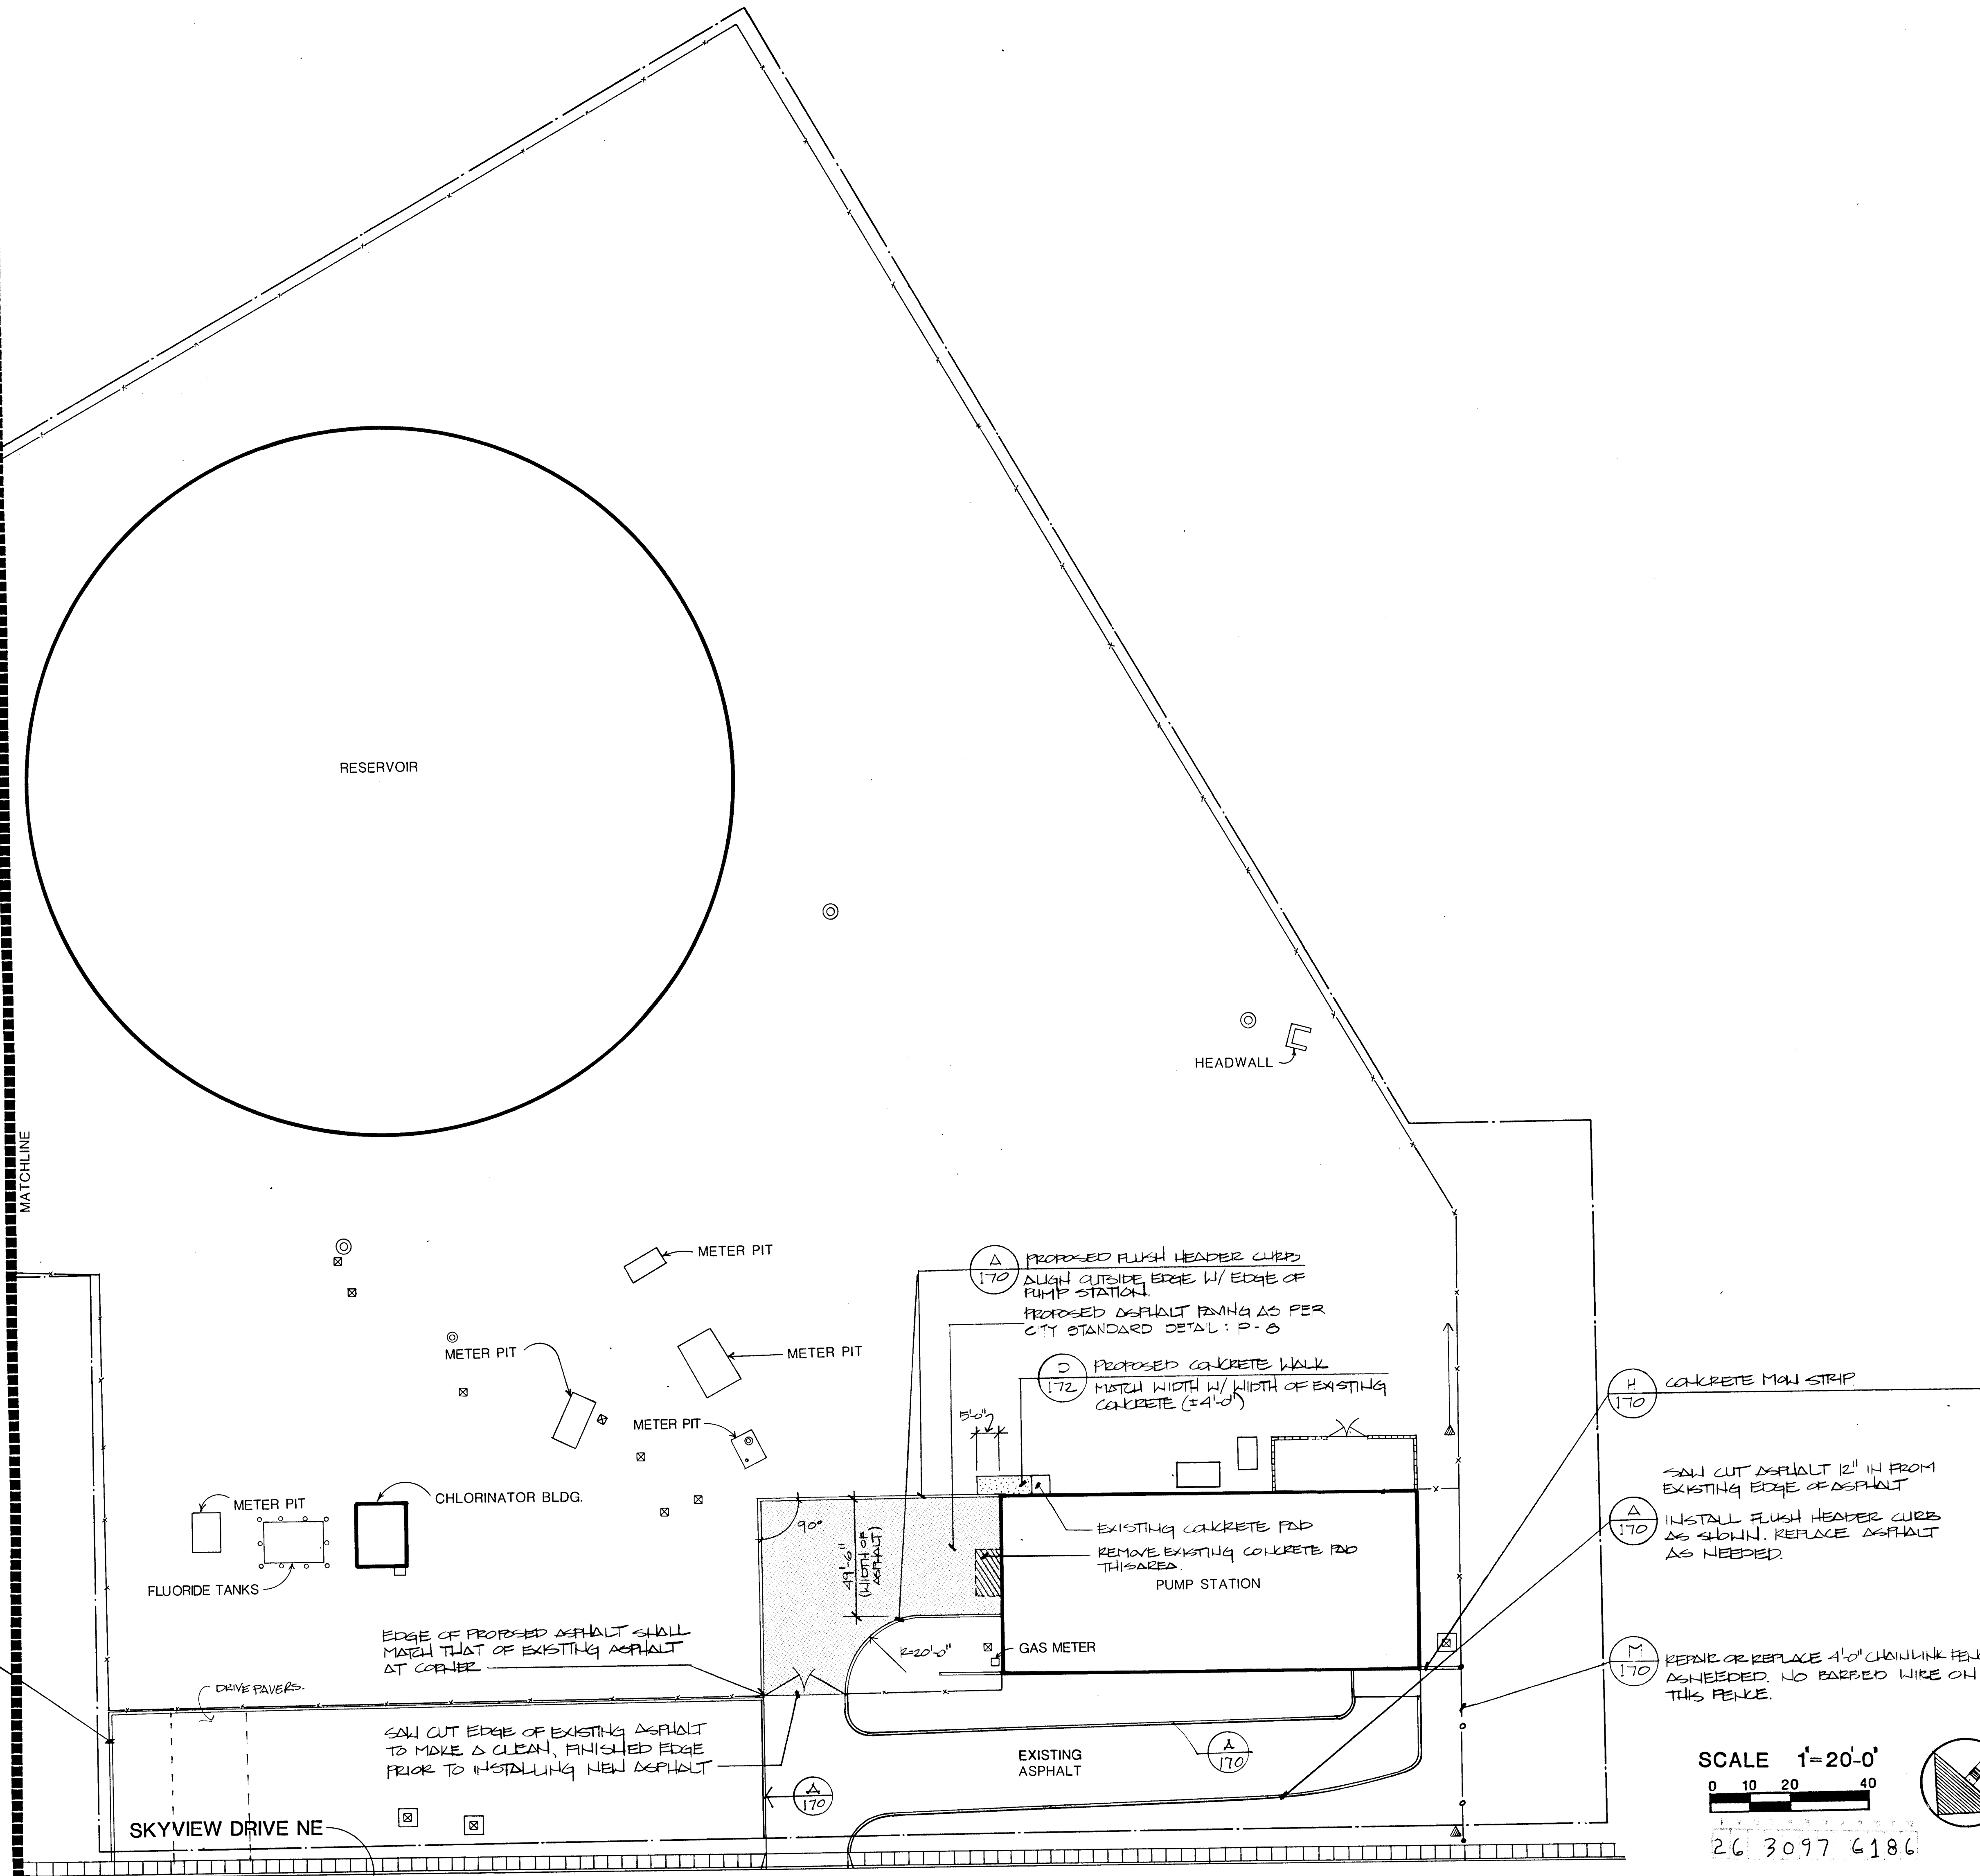

H
170 CONCRETE MAN STRIP
INSTALL MAN STRIP 2" FROM NORTH
FENCE LINE AND ALIGN W/ EAST
FENCE AS SHOWN.

METER PIT
FLUORIDE TANKS
CHLORINATOR BLDG.
METER PIT
METER PIT
METER PIT

EDGE OF PROPOSED ASPHALT SHALL
MATCH THAT OF EXISTING ASPHALT
AT CORNER

SAW CUT EDGE OF EXISTING ASPHALT
TO MAKE A CLEAN, FINISHED EDGE
PRIOR TO INSTALLING NEW ASPHALT

A
170 PROPOSED FLUSH HEADER CURB
ALIGN OUTSIDE EDGE W/ EDGE OF
PUMP STATION.
PROPOSED ASPHALT FINISH AS PER
CITY STANDARD DETAIL: P-8

D
172 PROPOSED CONCRETE WALK
MATCH WIDTH W/ WIDTH OF EXISTING
CONCRETE (±4'-0")

EXISTING CONCRETE PAD
REMOVE EXISTING CONCRETE PAD
THIS AREA
PUMP STATION
GAS METER


H
170 CONCRETE MAN STRIP

A
170 SAW CUT ASPHALT 12" IN FROM
EXISTING EDGE OF ASPHALT
INSTALL FLUSH HEADER CURB
AS SHOWN. REPLACE ASPHALT
AS NEEDED.

M
170 REPAIR OR REPLACE 4'-0" CHAINLINK FENCE
AS NEEDED. NO BARBED WIRE ON
THIS FENCE.

SCALE 1"=20'-0"
0 10 20 40

26 3097 6186

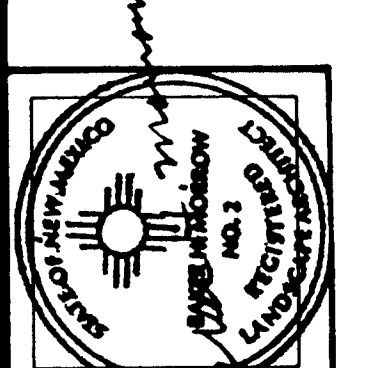


MORROW & COMPANY
LANDSCAPE ARCHITECTS
210 La Veta Drive NE
Albuquerque, New Mexico 87108
505-268-2266

NOVEMBER
1986

LOMAS RESERVOIR #1 & #2 & PUMP STATION
13200 SKYVIEW DRIVE NE
CONSTRUCTION PLAN
AS BUILT

LANDSCAPING IMPROVEMENTS FOR
WATER SYSTEM FACILITY SITES
WATER SYSTEMS DIVISION
CITY OF ALBUQUERQUE
ALBUQUERQUE, NEW MEXICO

SHEET
73
OF
172

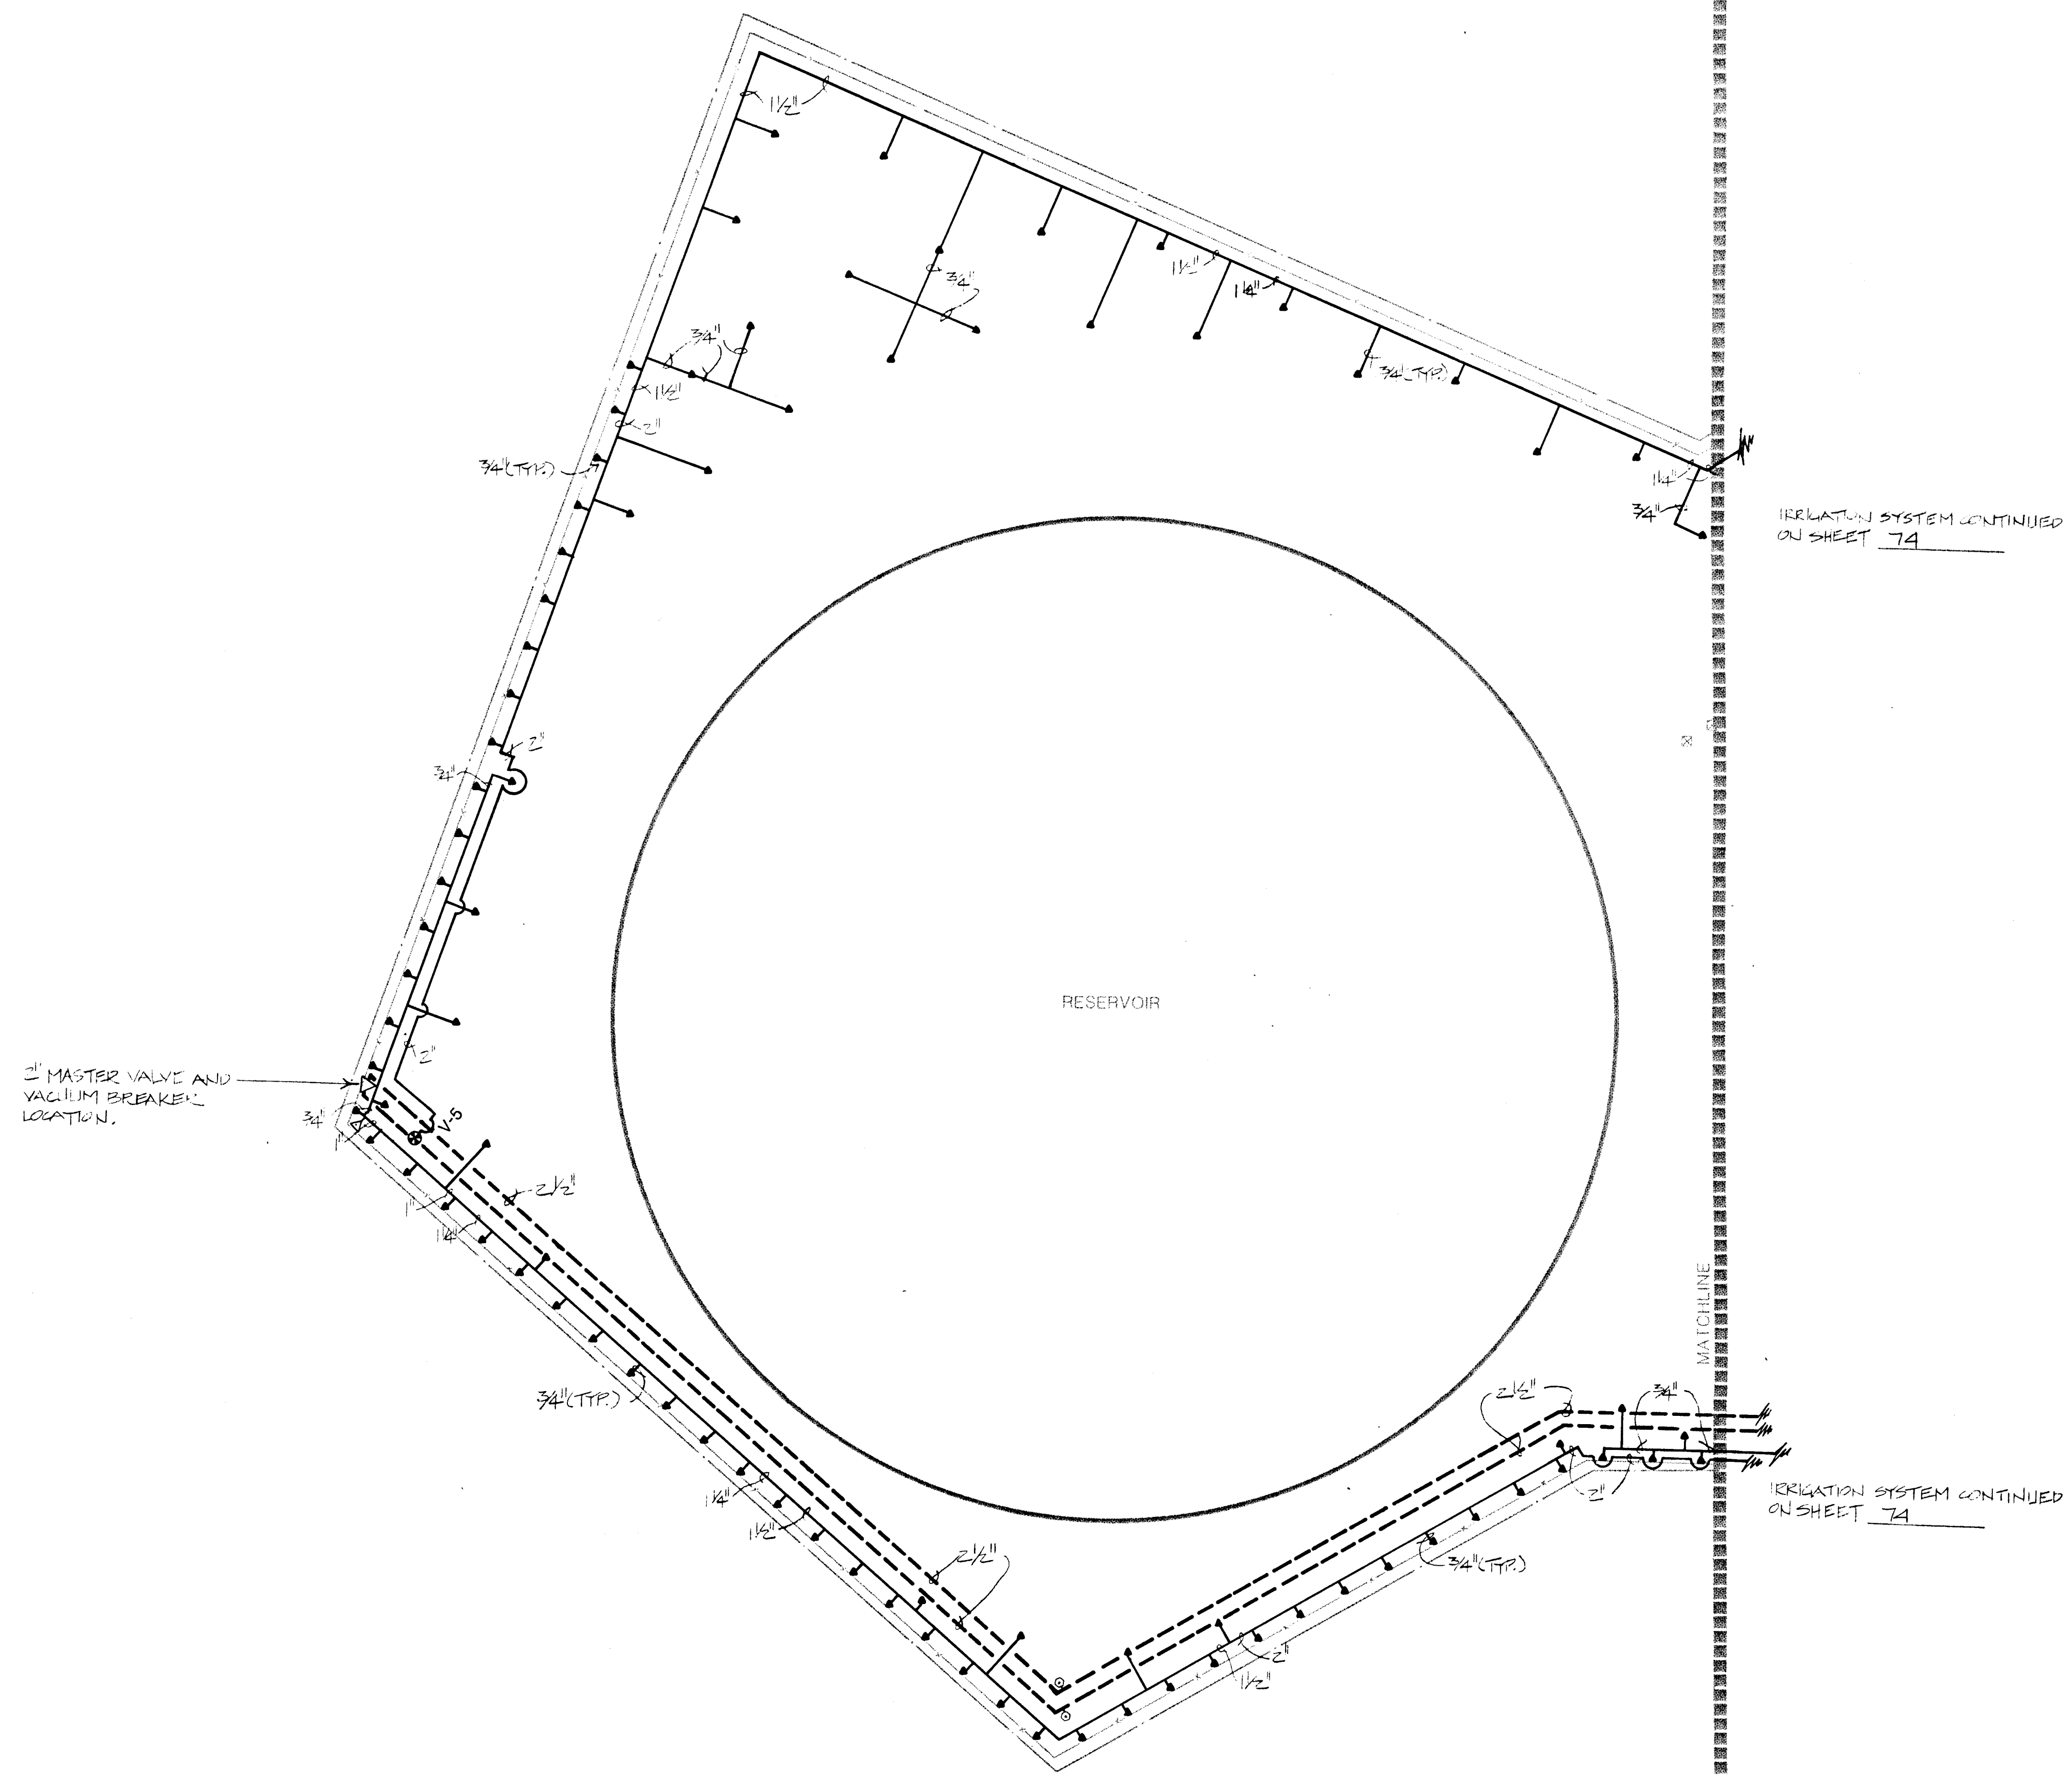

26 3097 6386

SCALE 1"=20'-0"

0 10 20 40

MORROW & COMPANY
LANDSCAPE ARCHITECTS
210 La Veta Drive NE
Albuquerque, New Mexico 87108
505-268-2266


NOVEMBER 1986

LOMAS RESERVOIR #1 & #2 & PUMP STATION
13200 SKYVIEW DRIVE NE
IRRIGATION PLAN

AS BUILT

LANDSCAPING IMPROVEMENTS FOR
WATER SYSTEM FACILITY SITES
WATER SYSTEMS DIVISION
CITY OF ALBUQUERQUE
ALBUQUERQUE, NEW MEXICO

SHEET
79
OF
172

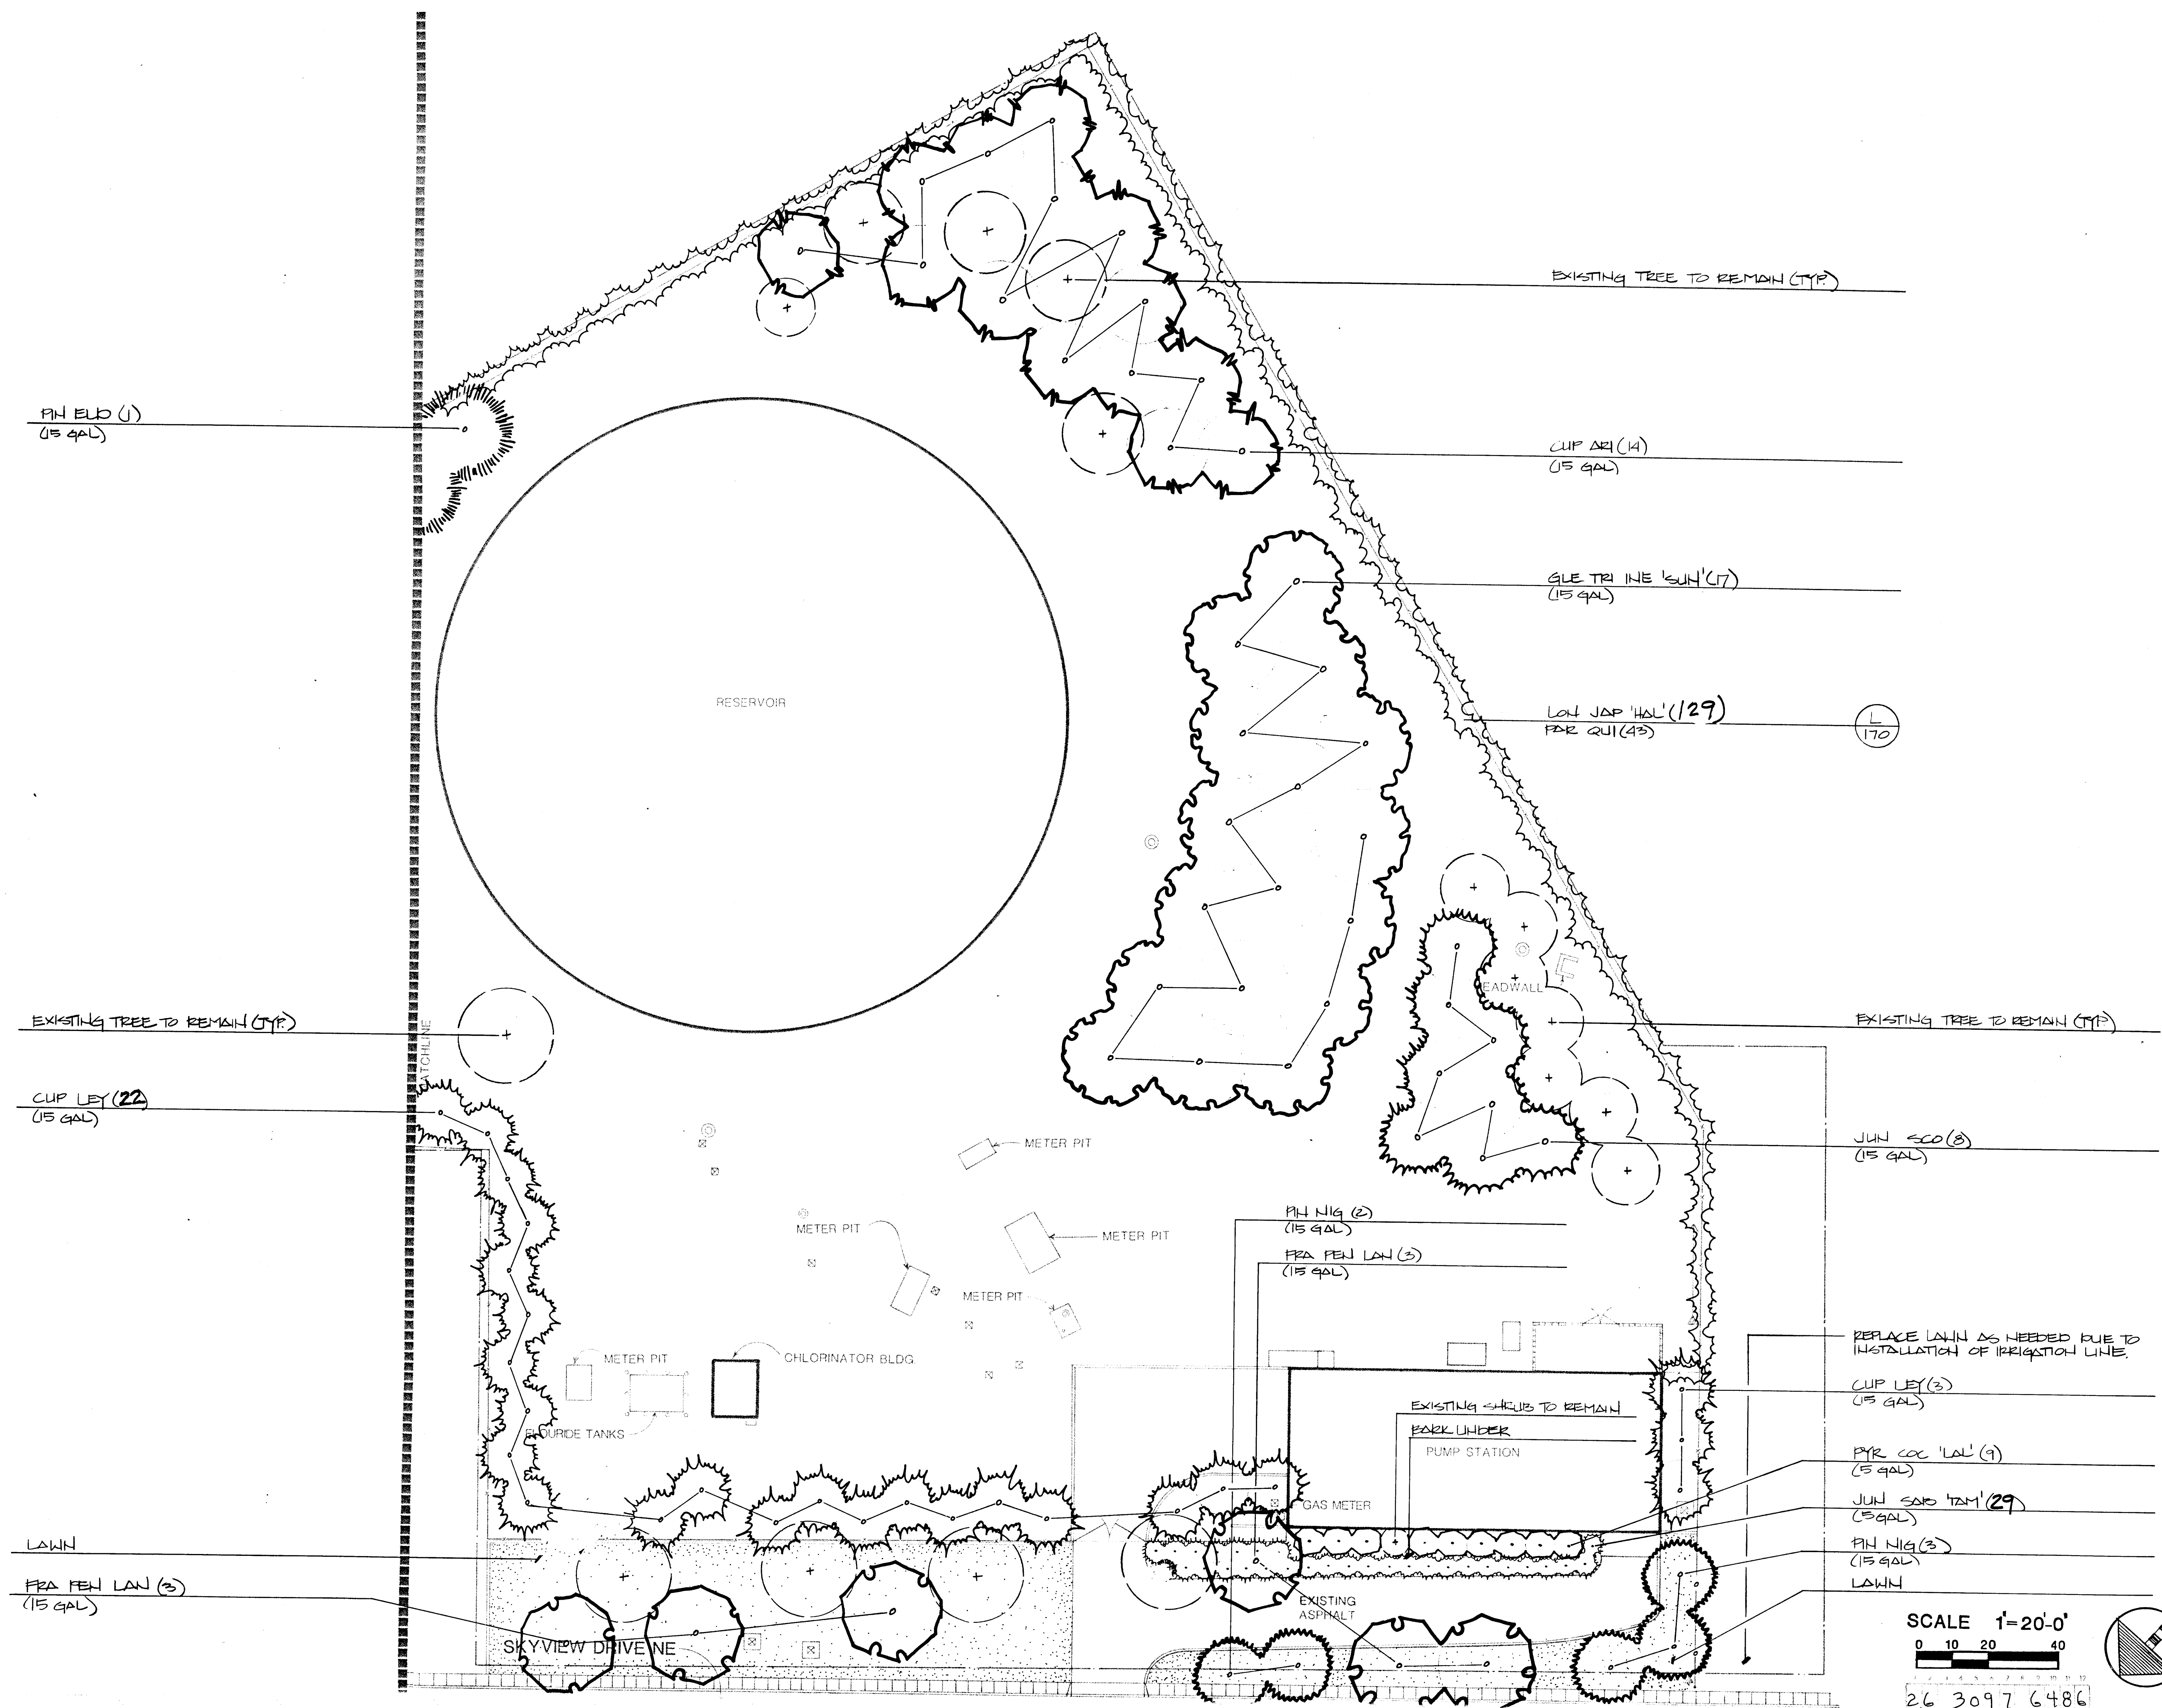

MORROW & COMPANY
LANDSCAPE ARCHITECTS
210 La Veta Drive NE
Albuquerque, New Mexico 87108
505.268.2200

NOVEMBER
1998

LOMAS RESERVOIR #1 & #2 & PUMP STATION
13200 SKYVIEW DRIVE NE
PLANTING PLAN



LANDSCAPING IMPROVEMENTS FOR
WATER SYSTEM FACILITY SITES

AS BUILT


LANDSCAPING IMPROVEMENTS FOR
WATER SYSTEM FACILITY SITES
13200 SKYVIEW DRIVE NE
ALBUQUERQUE, NEW MEXICO

SHEET
710
172

SCALE 1"=20'-0"
0 10 20 40
26 3097 6486

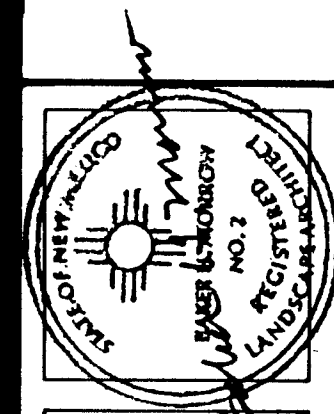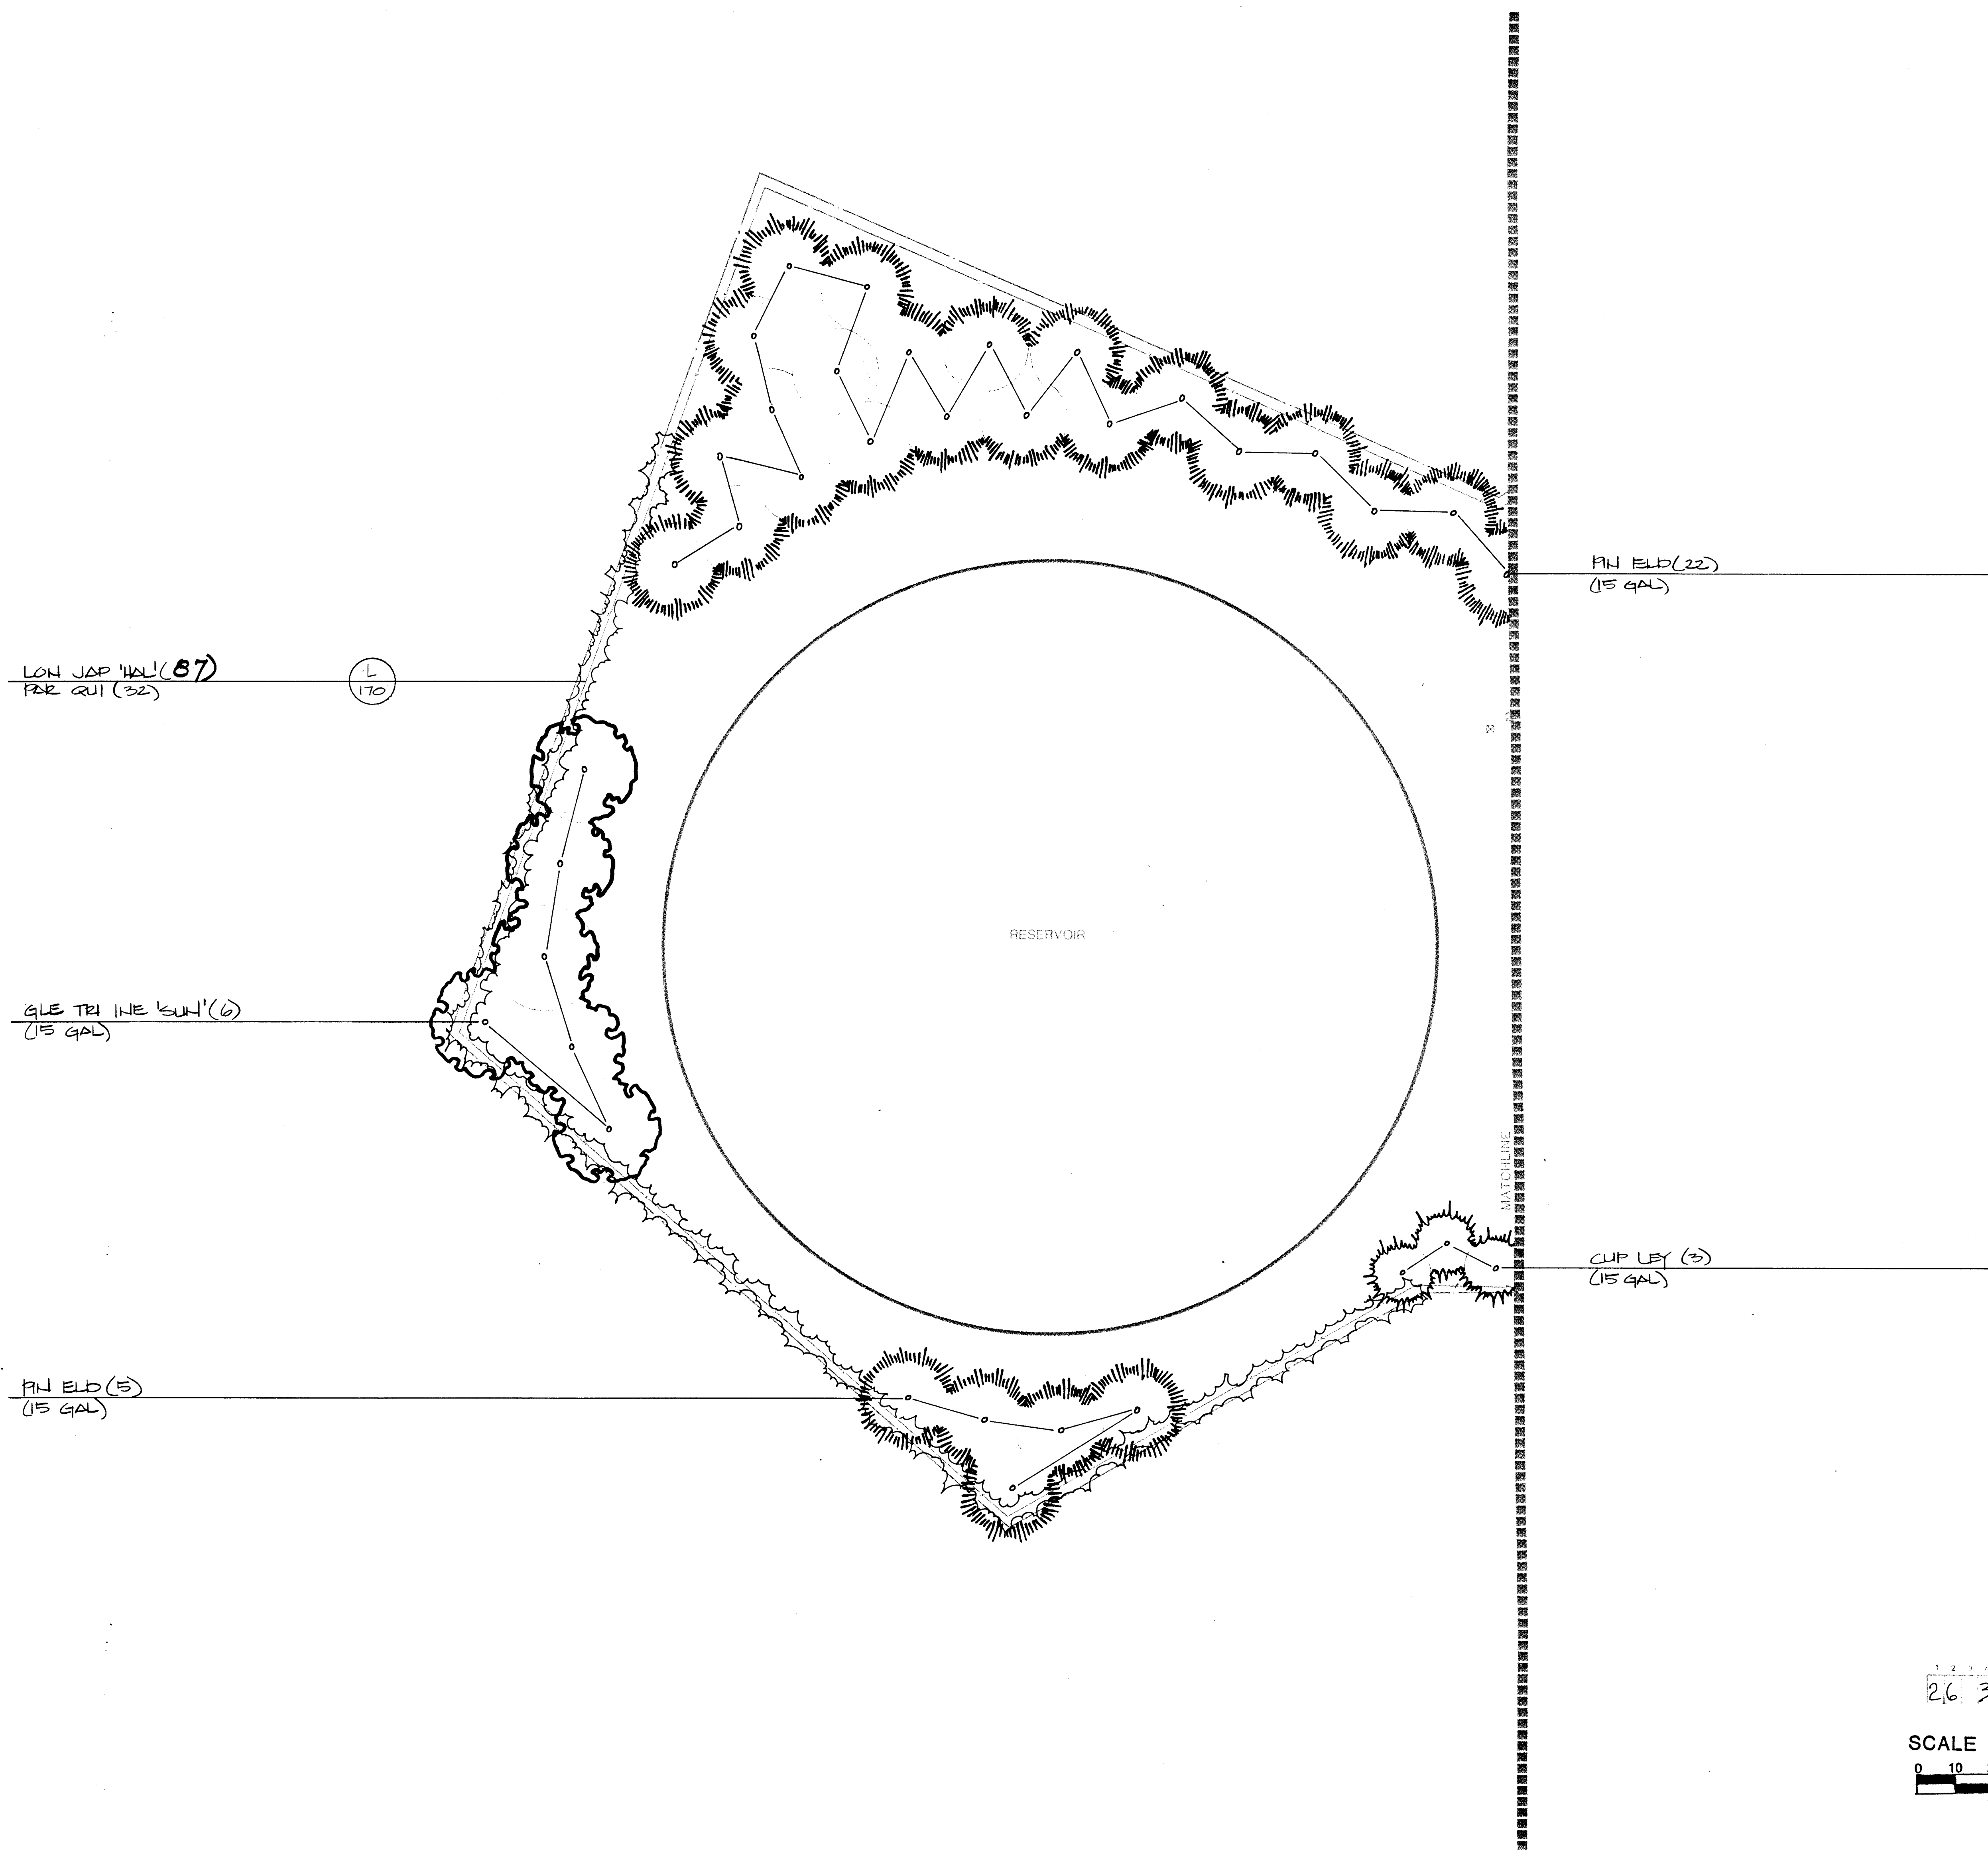

MORROW & COMPANY
LANDSCAPE ARCHITECTS
210 La Veta Drive NE
Albuquerque, New Mexico 87108
505-268-2268

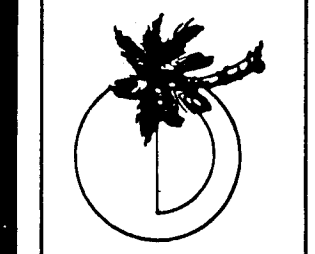


NOVEMBER
1986

LOMAS RESERVOIR #1 & #2 & PUMP STATION
13200 SKYVIEW DRIVE NE
PLANTING PLAN

LANDSCAPING IMPROVEMENTS FOR
WATER SYSTEM FACILITY SITES
WATER SYSTEMS DIVISION
ALBUQUERQUE, NEW MEXICO



SHEET
171
172

AS BUILT

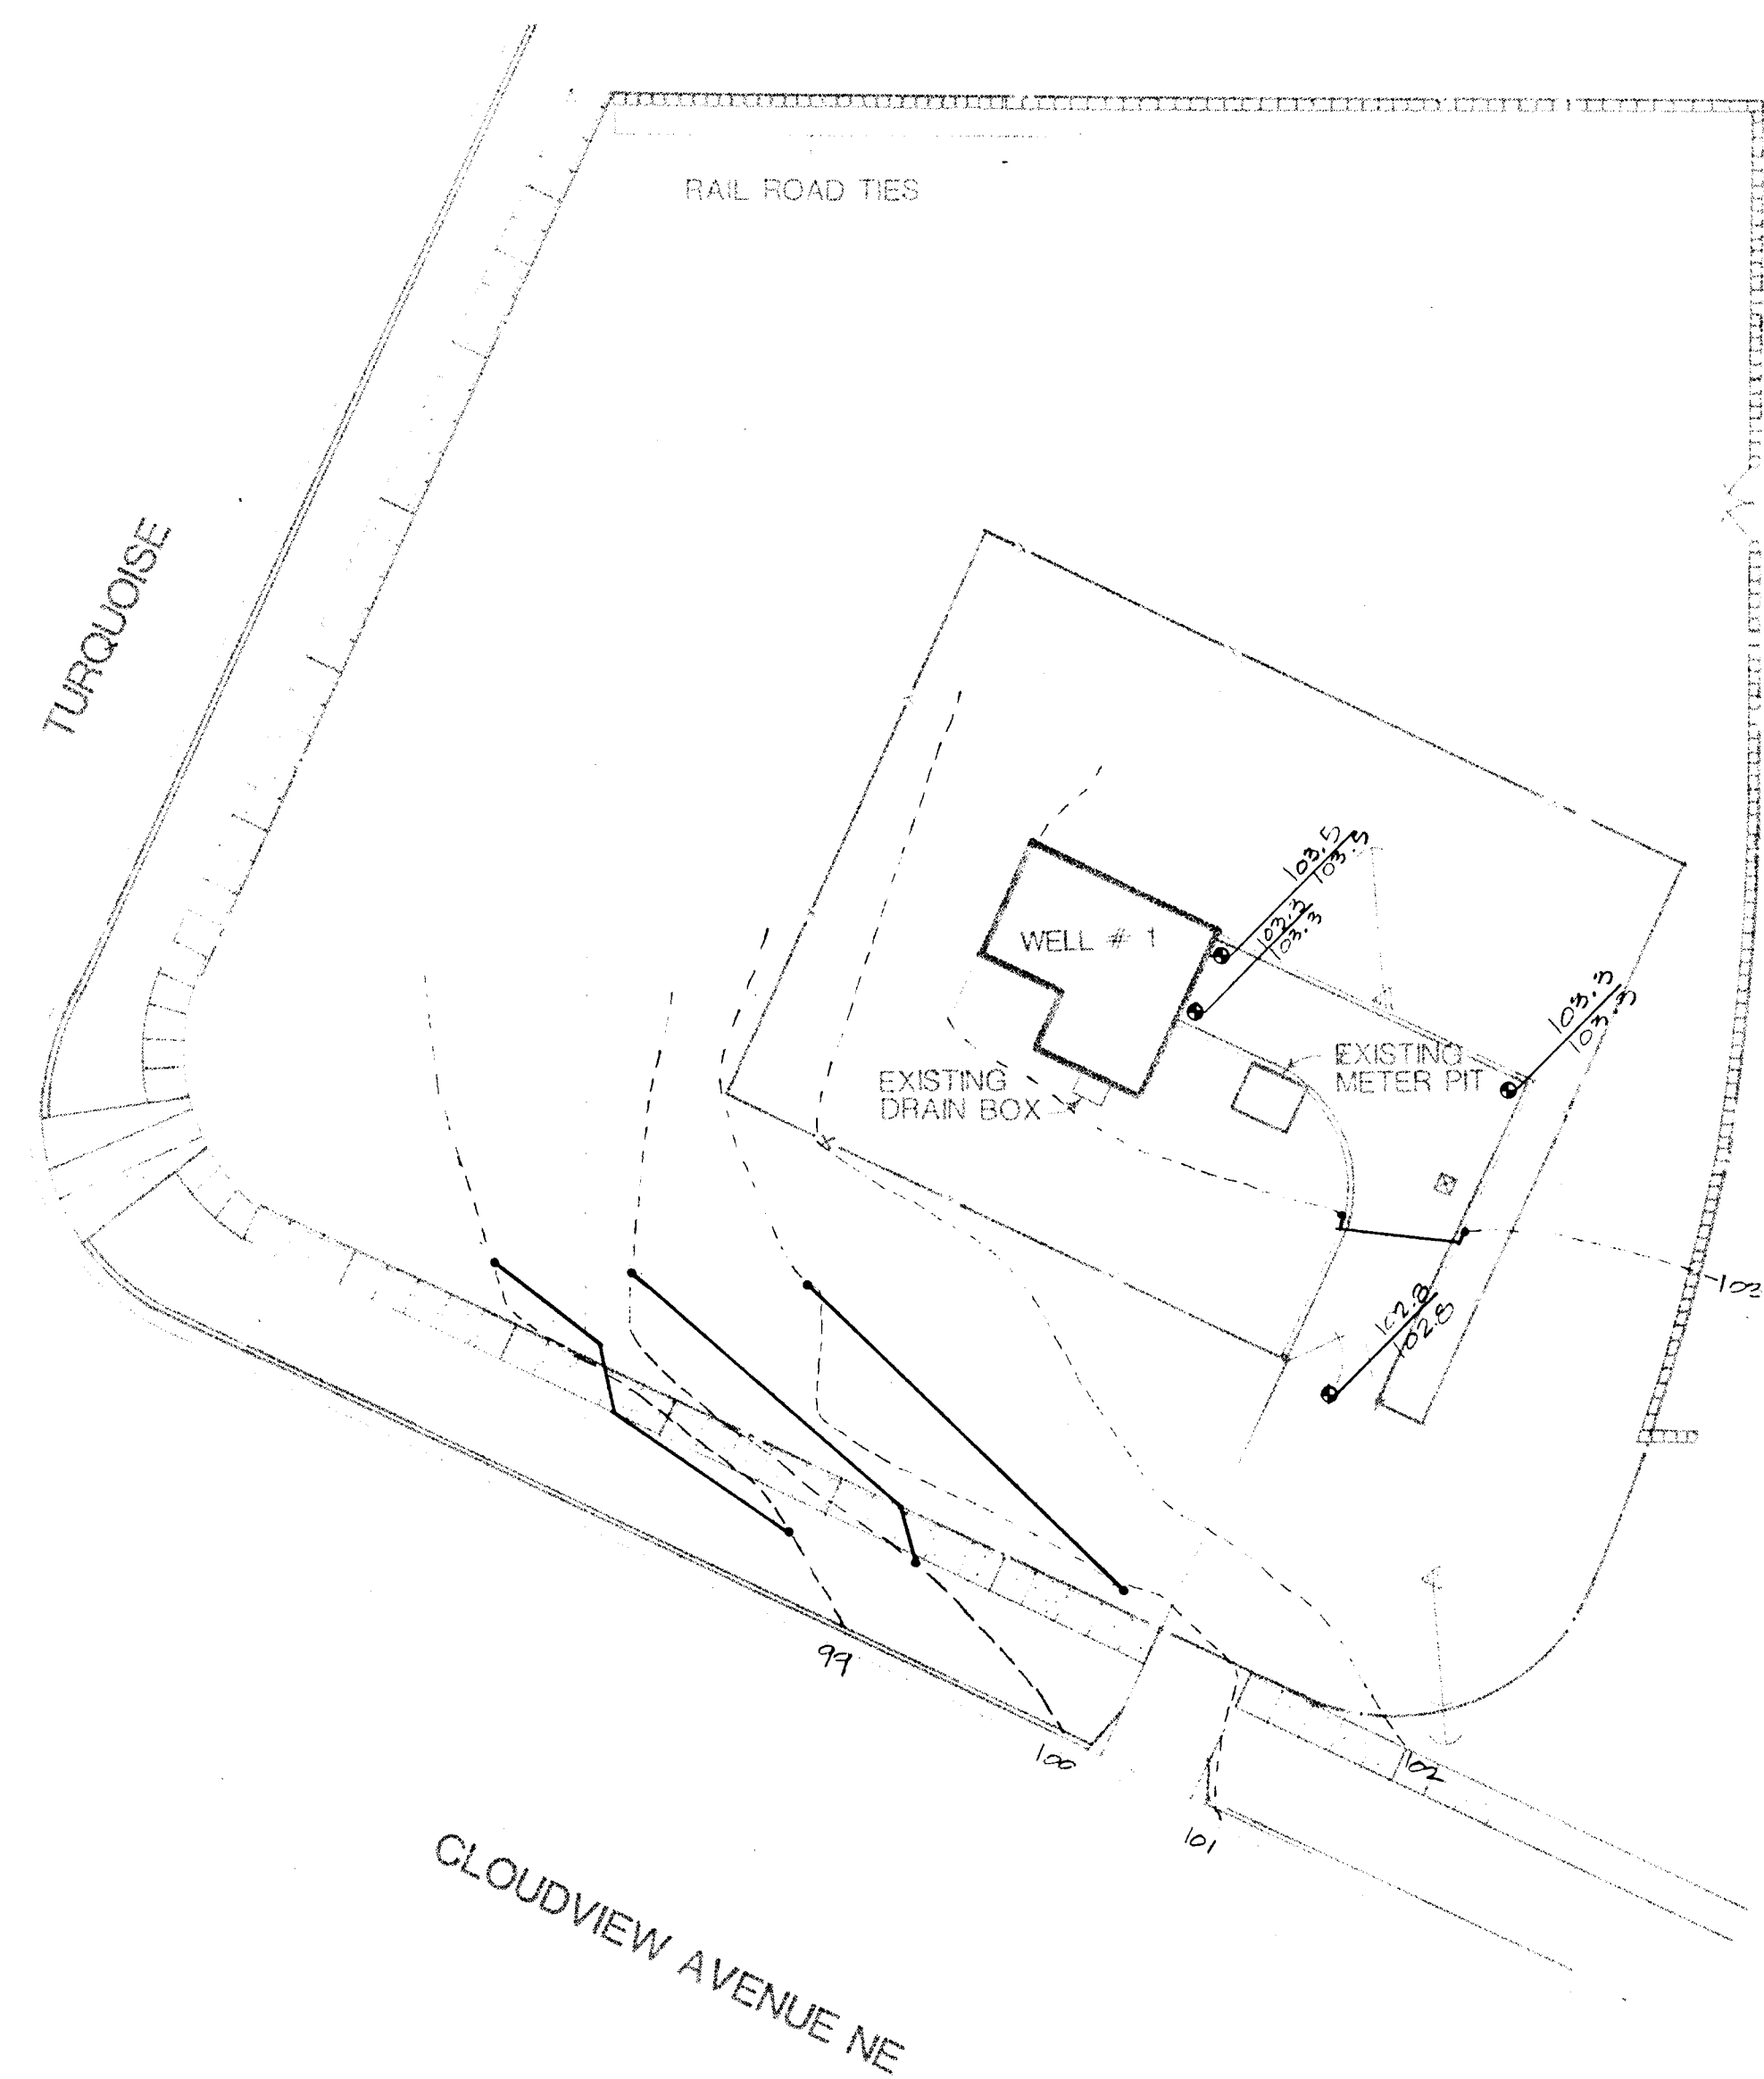

26 3097 6686

SCALE 1"=20'-0"

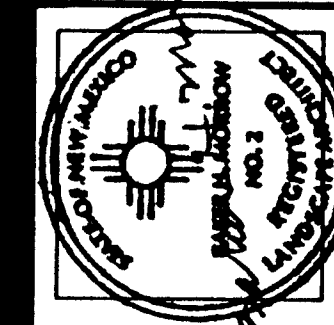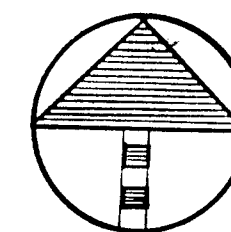

MORROW & COMPANY
LANDSCAPE ARCHITECTS
210 La Veta Drive NE
Albuquerque, New Mexico 87108
505 268 2288


NOVEMBER
1986

AS BUILT

LOMAS WELL #1
12503 CLOUDVIEW AVENUE NE
GRADING PLAN


LANDSCAPING IMPROVEMENTS FOR
WATER SYSTEM FACILITY SITES
WATER SYSTEM FACILITY SITES
CITY OF ALBUQUERQUE
ALBUQUERQUE, NEW MEXICO

SHEET
178
172

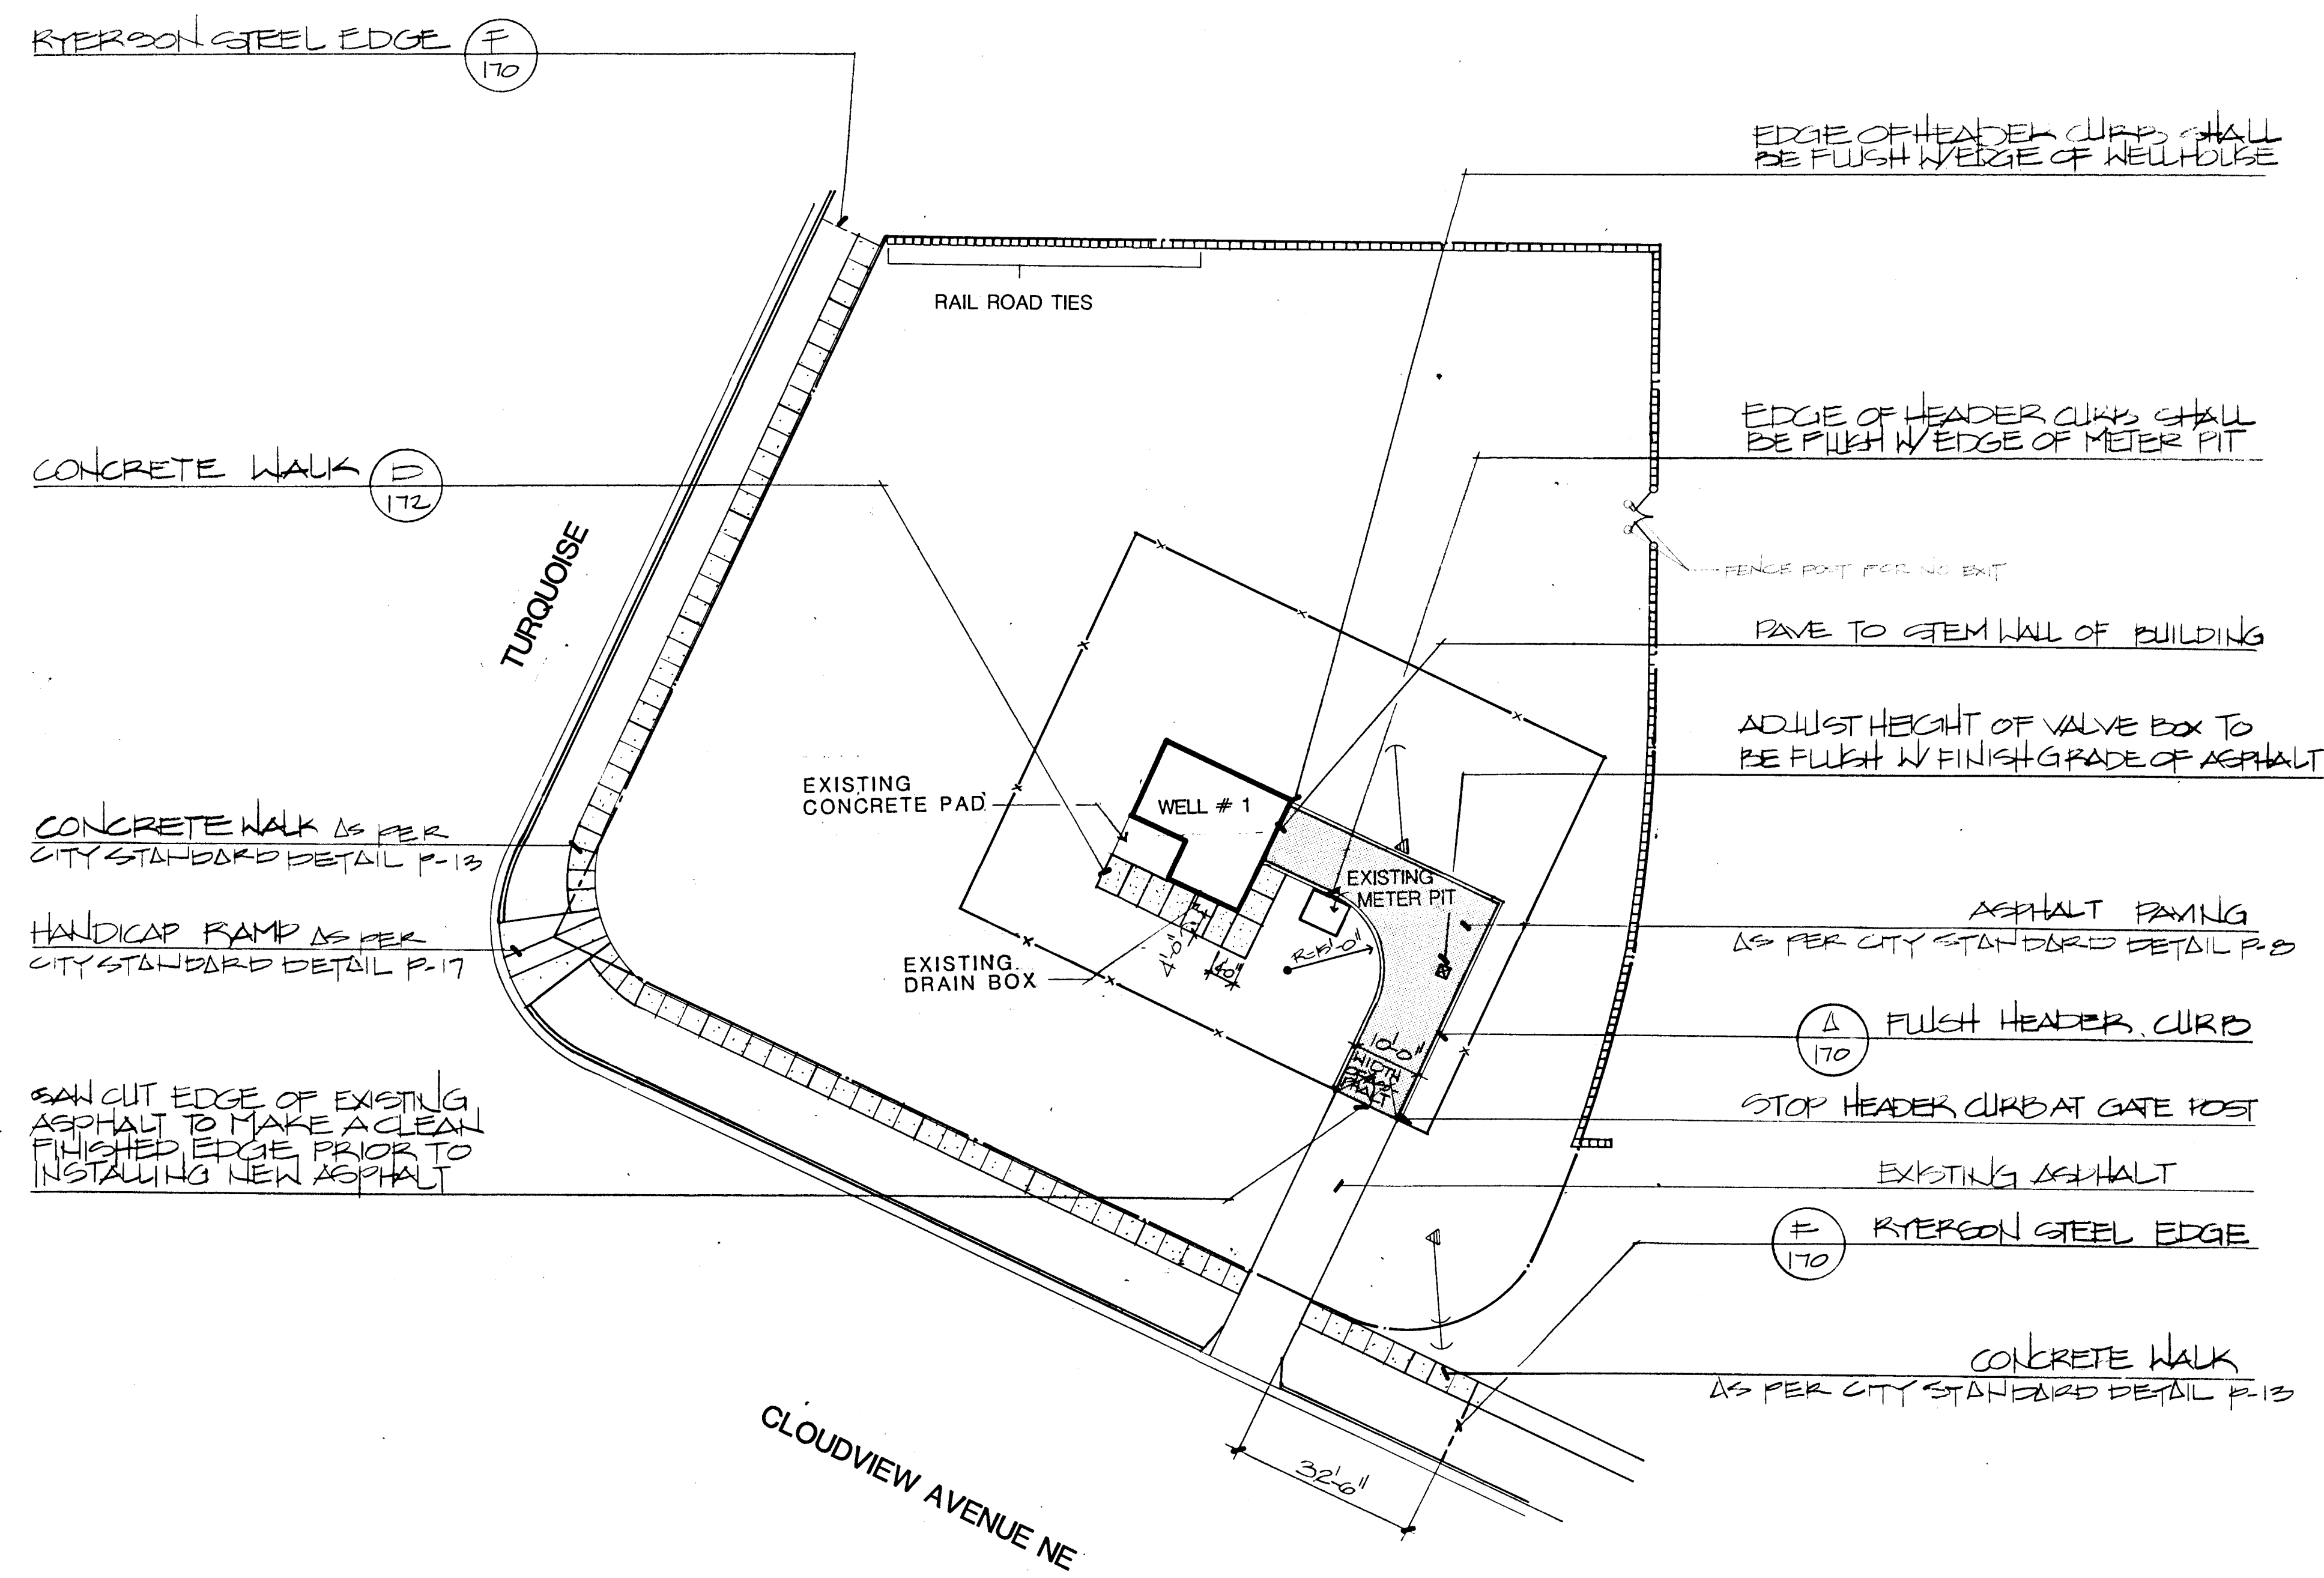

26 3097 6786

SCALE 1"=20'-0"

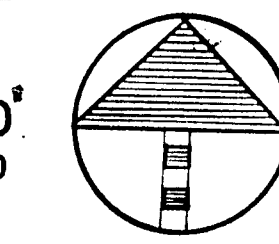

MORROW & COMPANY
LANDSCAPE ARCHITECTS
210 La Veta Drive NE
Albuquerque, New Mexico 87108
505-268-2260


NOVEMBER
1998

AS BUILT

LANDSCAPING IMPROVEMENTS FOR
WATER SYSTEM FACILITY SITES
WATER SYSTEMS DIVISION
CITY OF ALBUQUERQUE
ALBUQUERQUE, NEW MEXICO

LOMAS WELL #1
12503 CLOUDVIEW AVENUE NE
CONSTRUCTION PLAN

SHEET
172

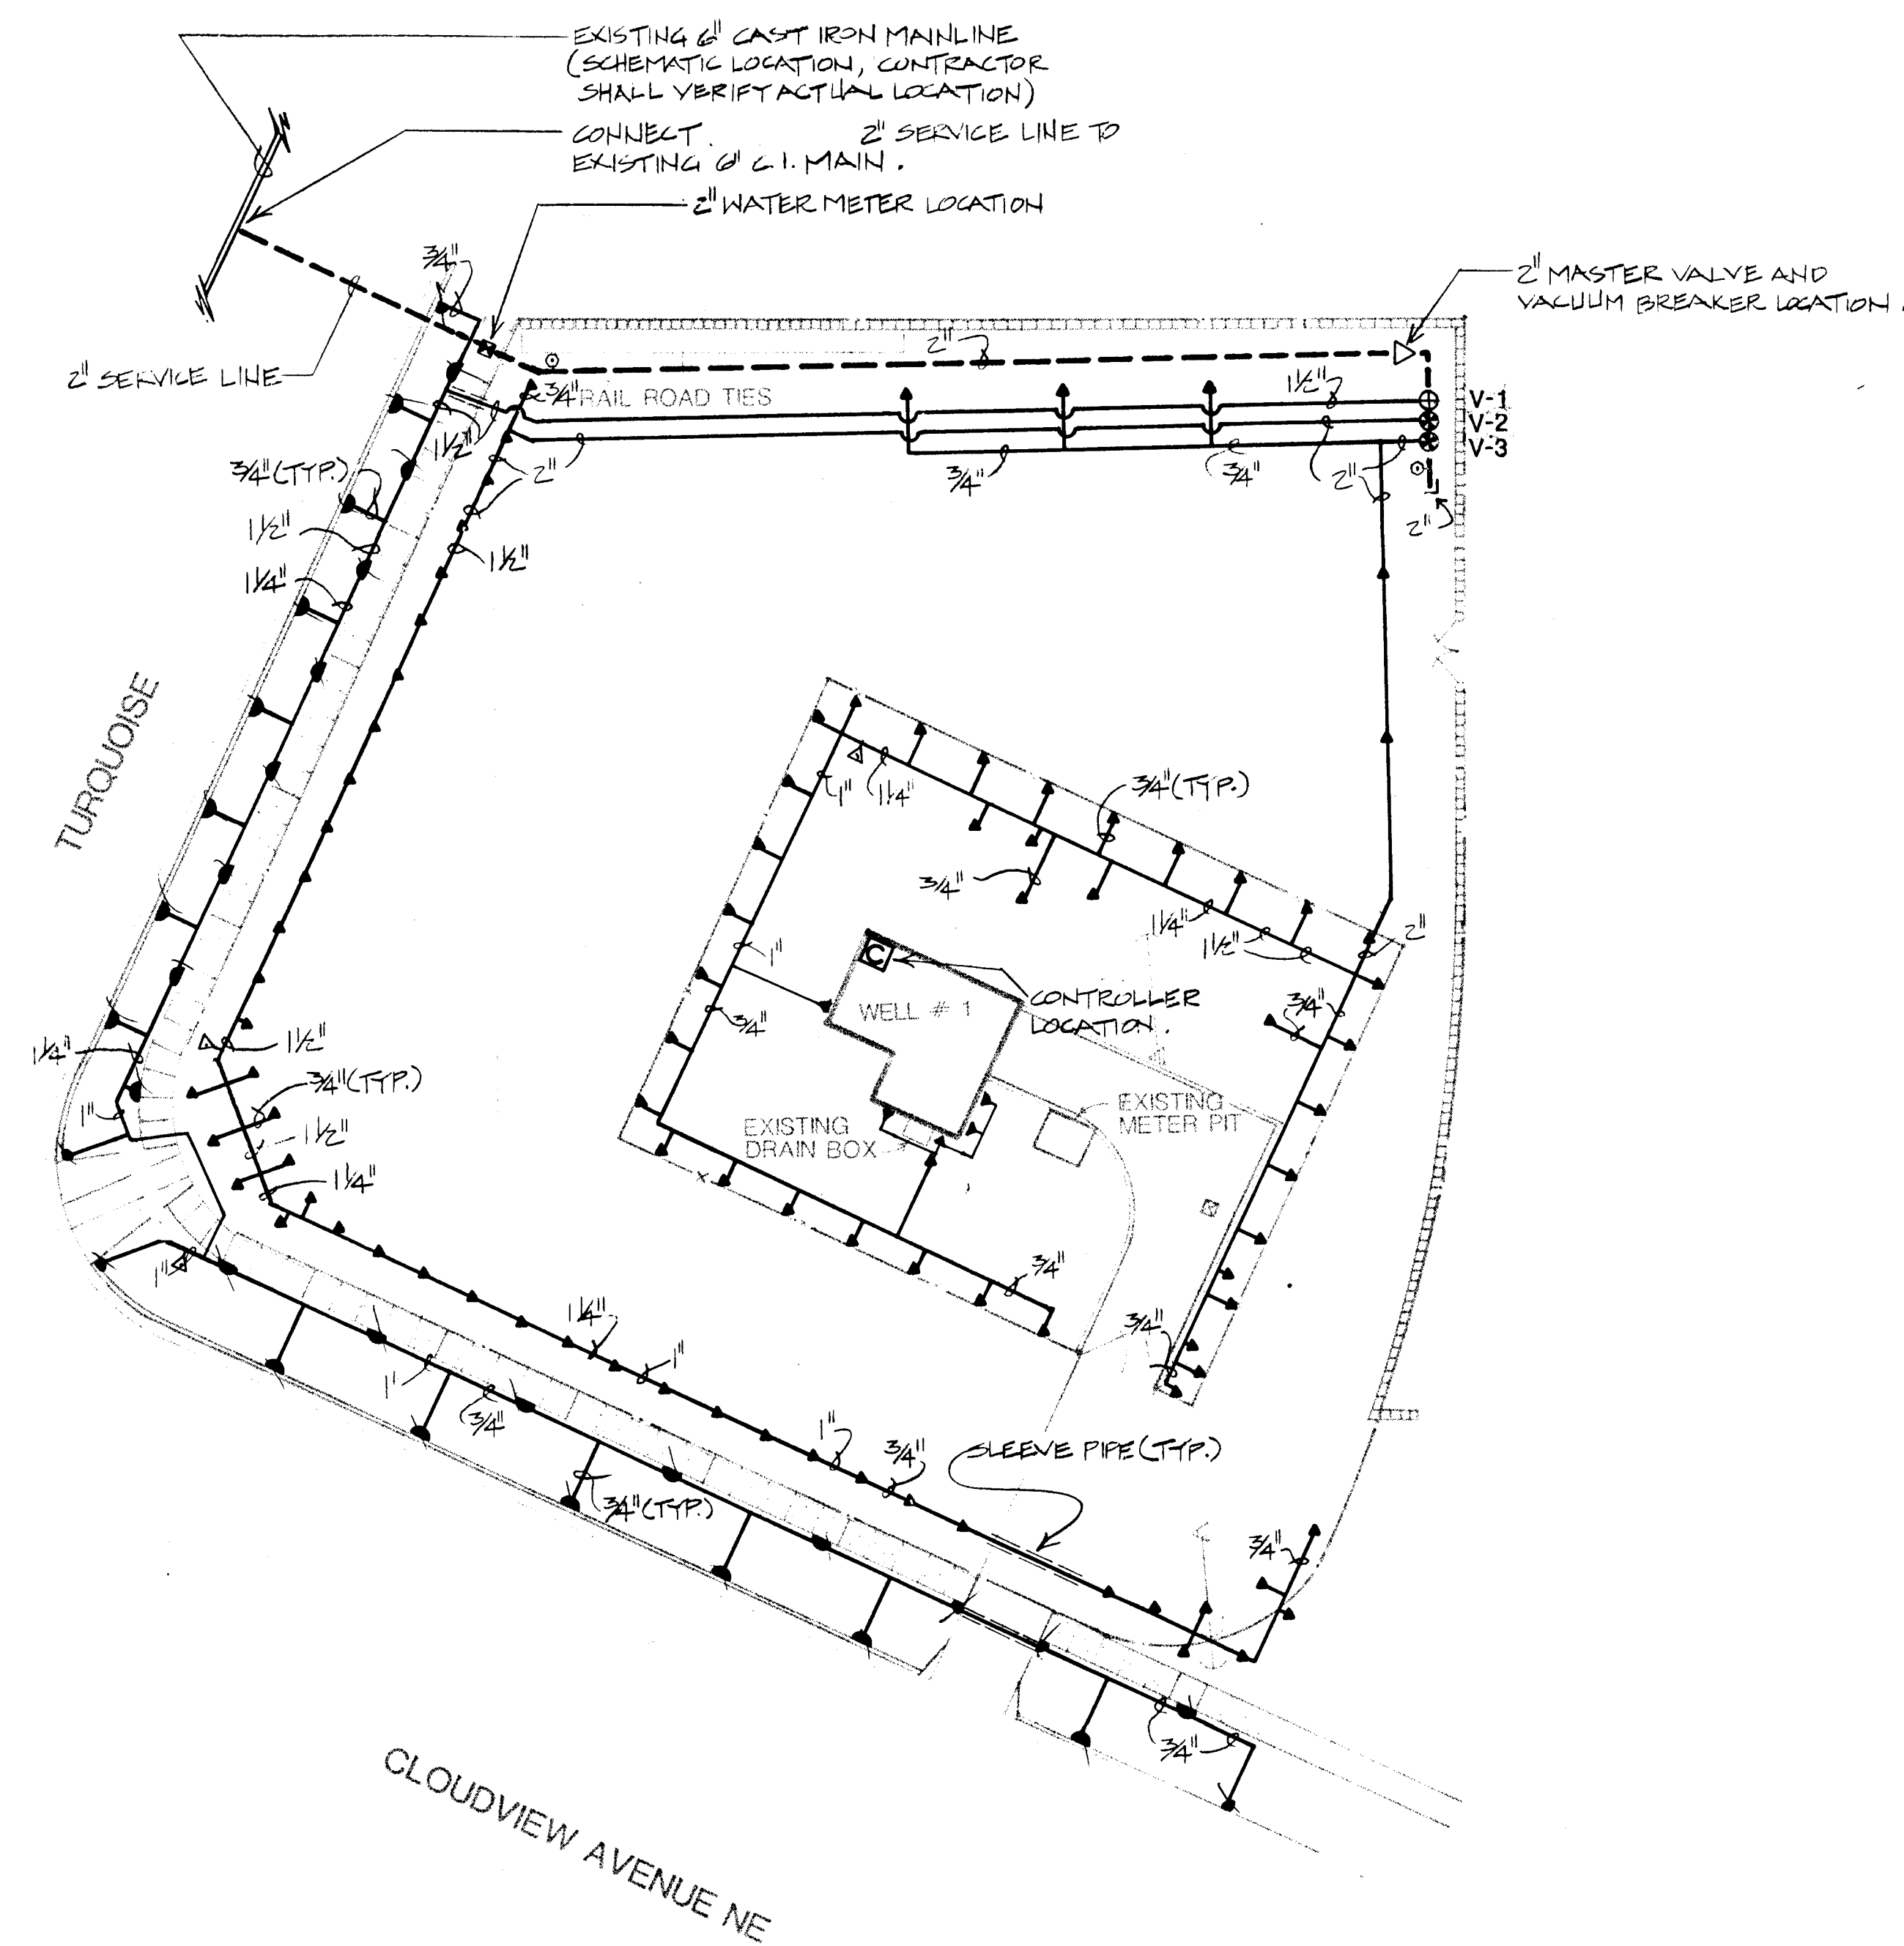

ELECTRICAL PANEL → IRRIGATION CONTROLLER

CIRCUIT #2

3/4" RIGID STEEL CONDUIT, 110 VOLT CIRCUIT



1 1/2" RIGID STEEL CONDUIT, 24 VOLT CIRCUITS
TO REMOTE CONTROL VALVES

SCHEMATIC AS BUILT FOR 110 VOLT ELECTRICAL
FROM SOURCE TO IRRIGATION CONTROLLER


26 3097 6886

SCALE 1"=20'-0"

0 10 20 40

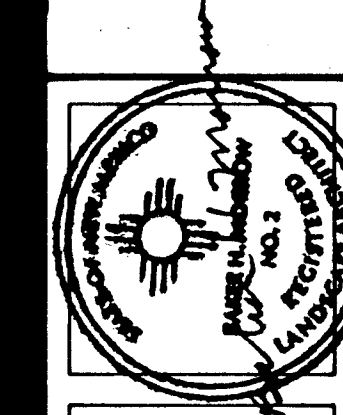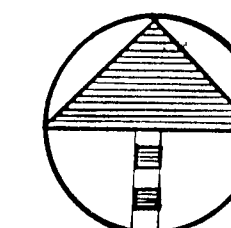

MORROW & COMPANY
LANDSCAPE ARCHITECTS
210 La Vista Drive NE
Albuquerque, New Mexico 87108
505-268-2266


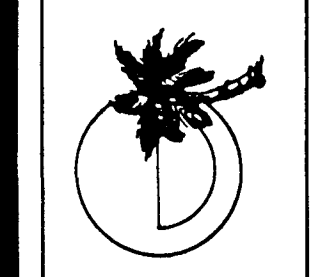


NOVEMBER
1986

AS BUILT
LOMAS WELL #1
12503 CLOUDVIEW AVENUE NE
IRRIGATION PLAN

LANDSCAPING IMPROVEMENTS FOR
WATER SYSTEM FACILITY SITES
WATER SYSTEMS DIVISION
CITY OF ALBUQUERQUE
ALBUQUERQUE, NEW MEXICO

SHEET
172

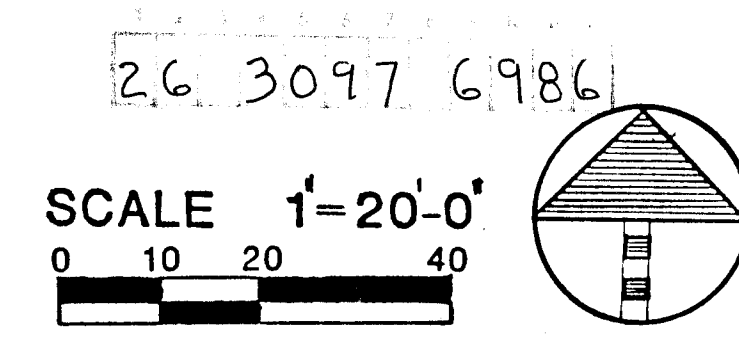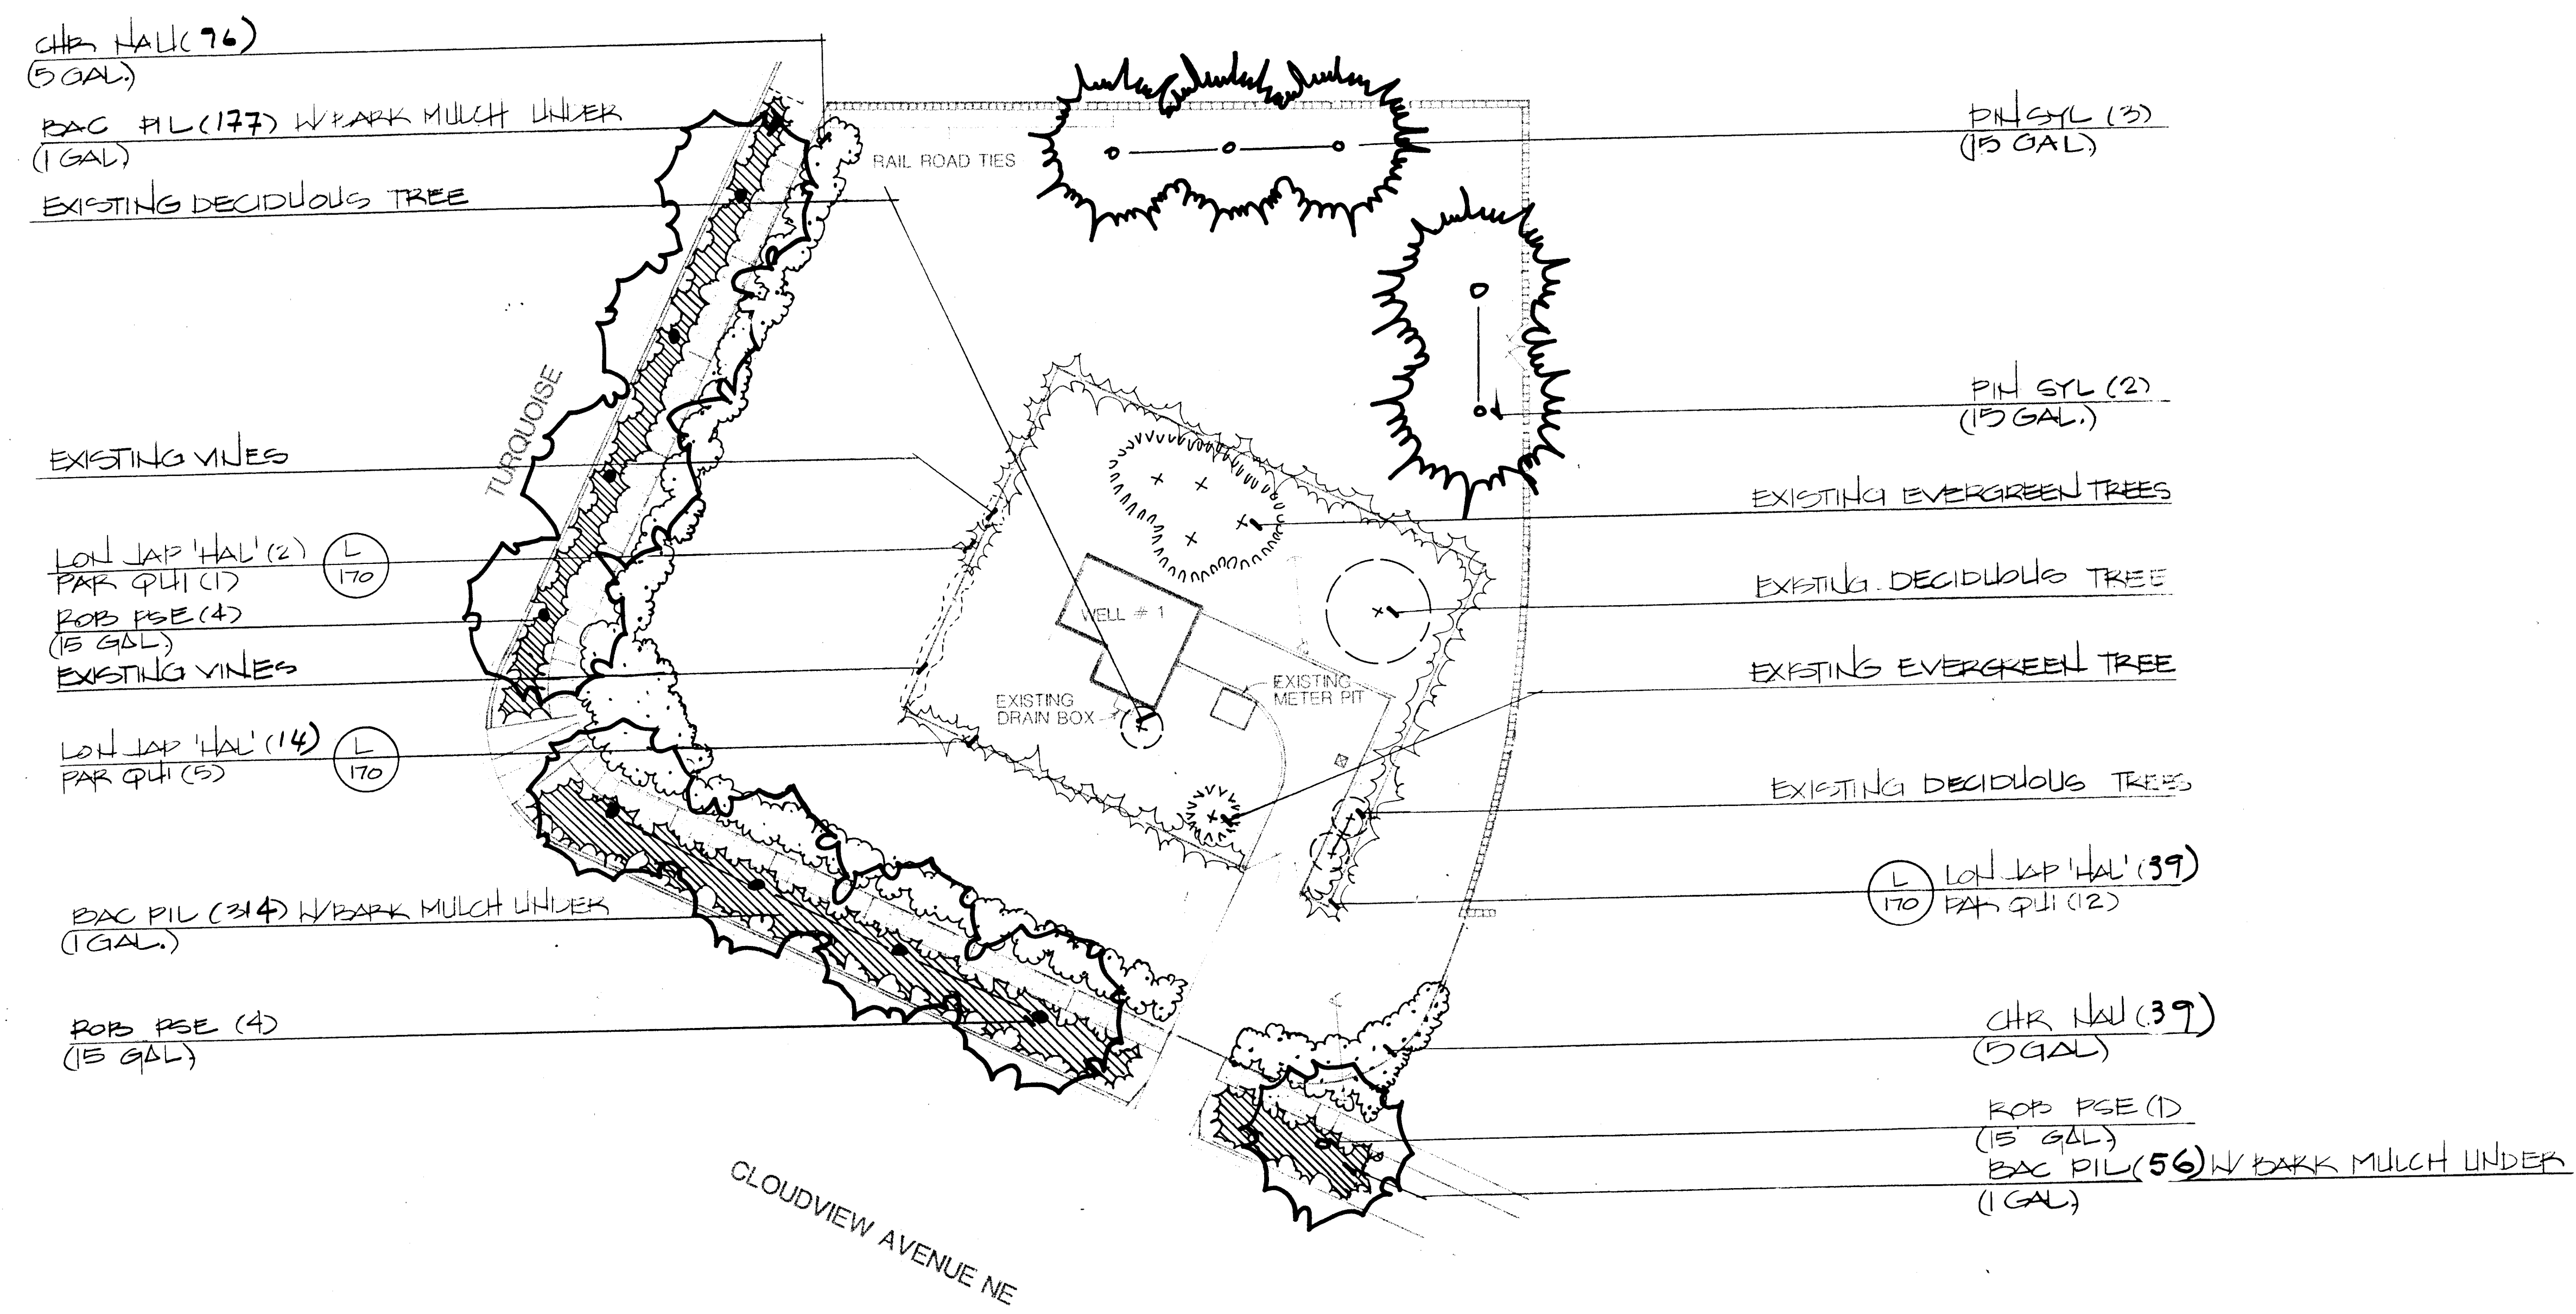

MORROW & COMPANY
 LANDSCAPE ARCHITECTS
 210 La Veta Drive NE
 Albuquerque, New Mexico 87108
 505-265-2266

LANDSCAPING IMPROVEMENTS FOR
 WATER SYSTEM FACILITY SITES
 WATER SYSTEMS DIVISION
 CITY OF ALBUQUERQUE, NEW MEXICO


AS BUILT

LOMAS WELL #1
 12503 CLOUDVIEW AVENUE NE
 PLANTING PLAN

NOVEMBER
 1986



SHEET

103
 172

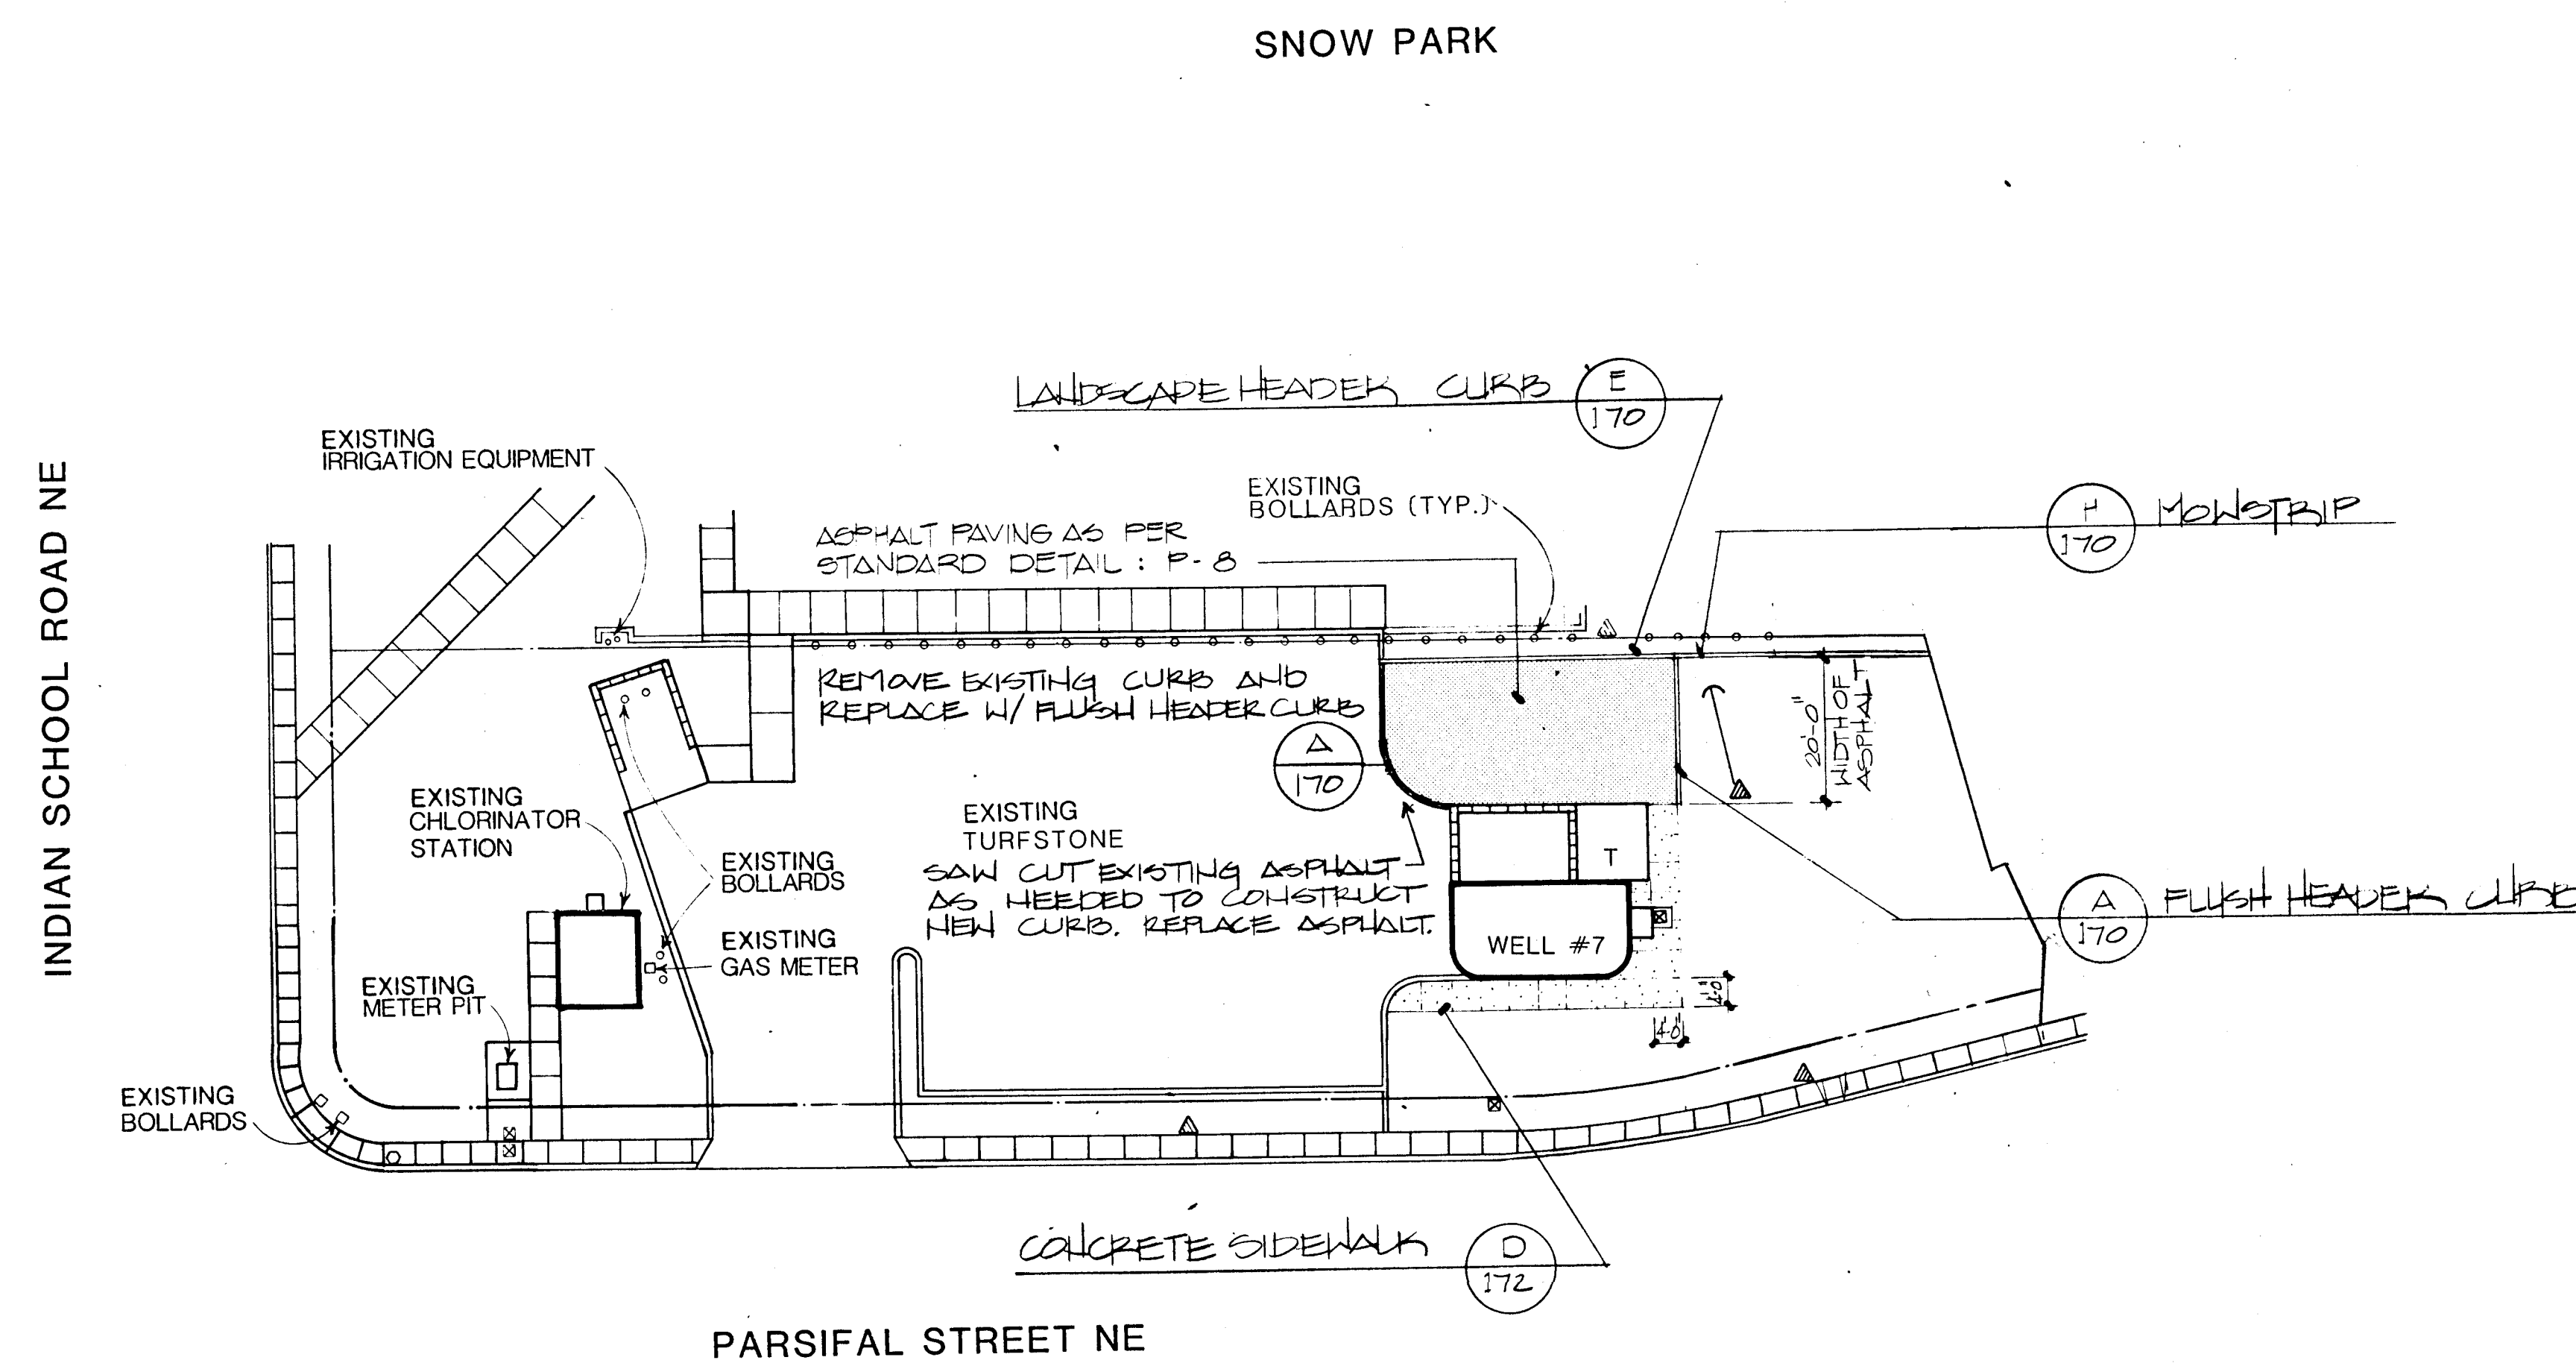


26.3097 71.86

SCALE 1"=20'-0"

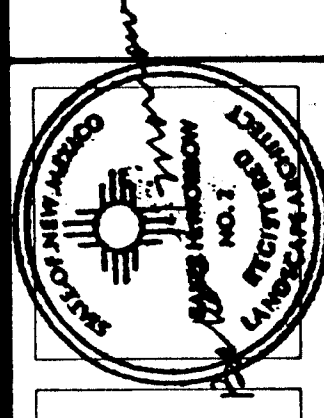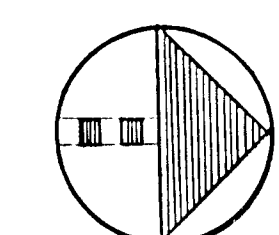

MORROW & COMPANY
LANDSCAPE ARCHITECTS
210 La Veta Drive NE
Albuquerque, New Mexico 87108
505-268-2266



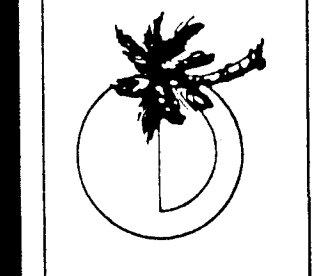


NOVEMBER
1986

AS BUILT
LOVE WELL #7
1815 PARSIFAL STREET NE
CONSTRUCTION PLAN

LANDSCAPING IMPROVEMENTS FOR
WATER SYSTEM FACILITY SITES
WATER RESOURCES DIVISION
CITY OF ALBUQUERQUE
ALBUQUERQUE, NEW MEXICO

SHEET
172

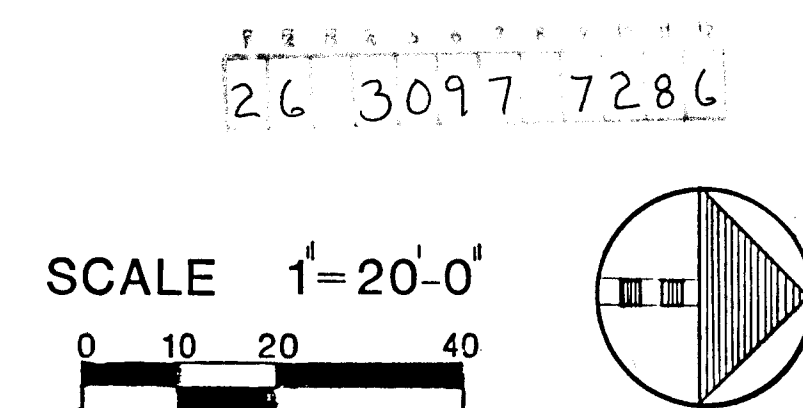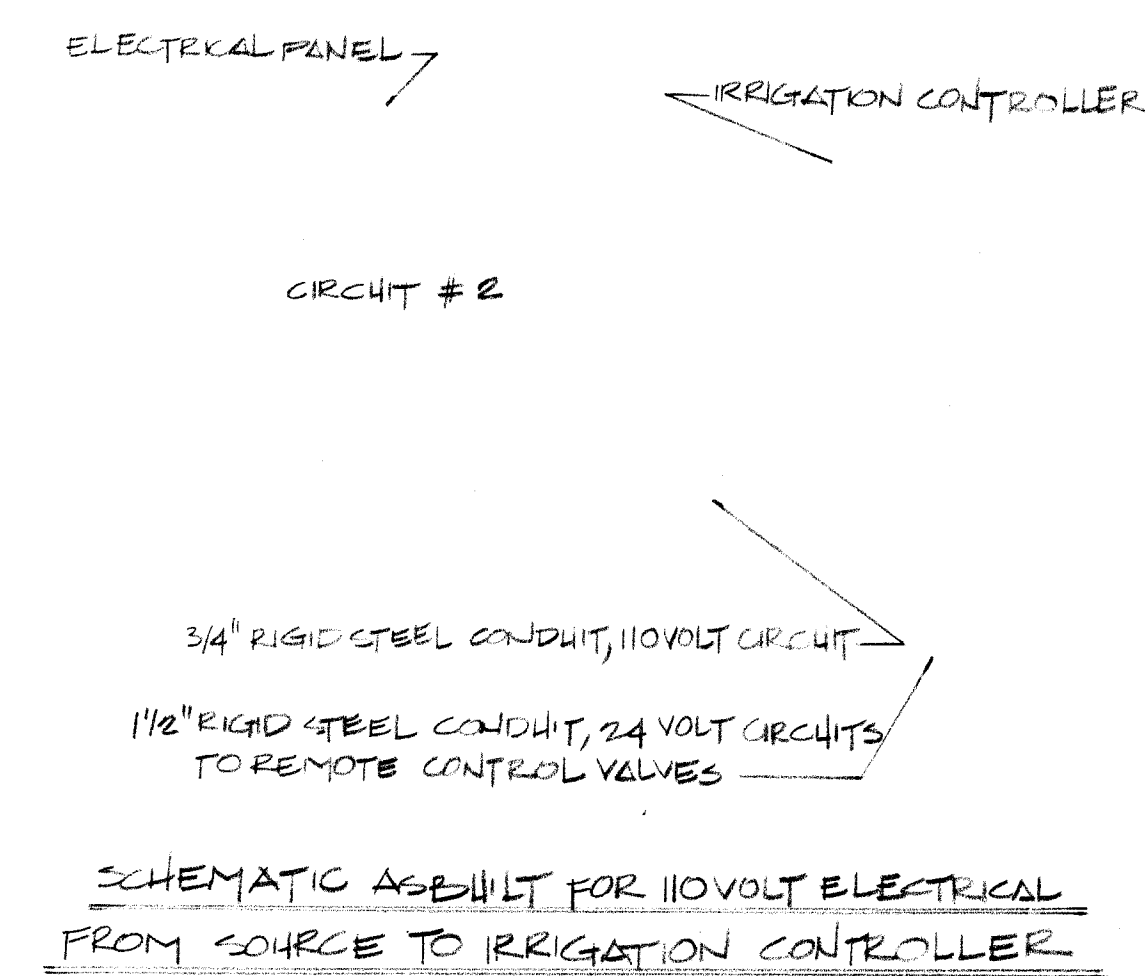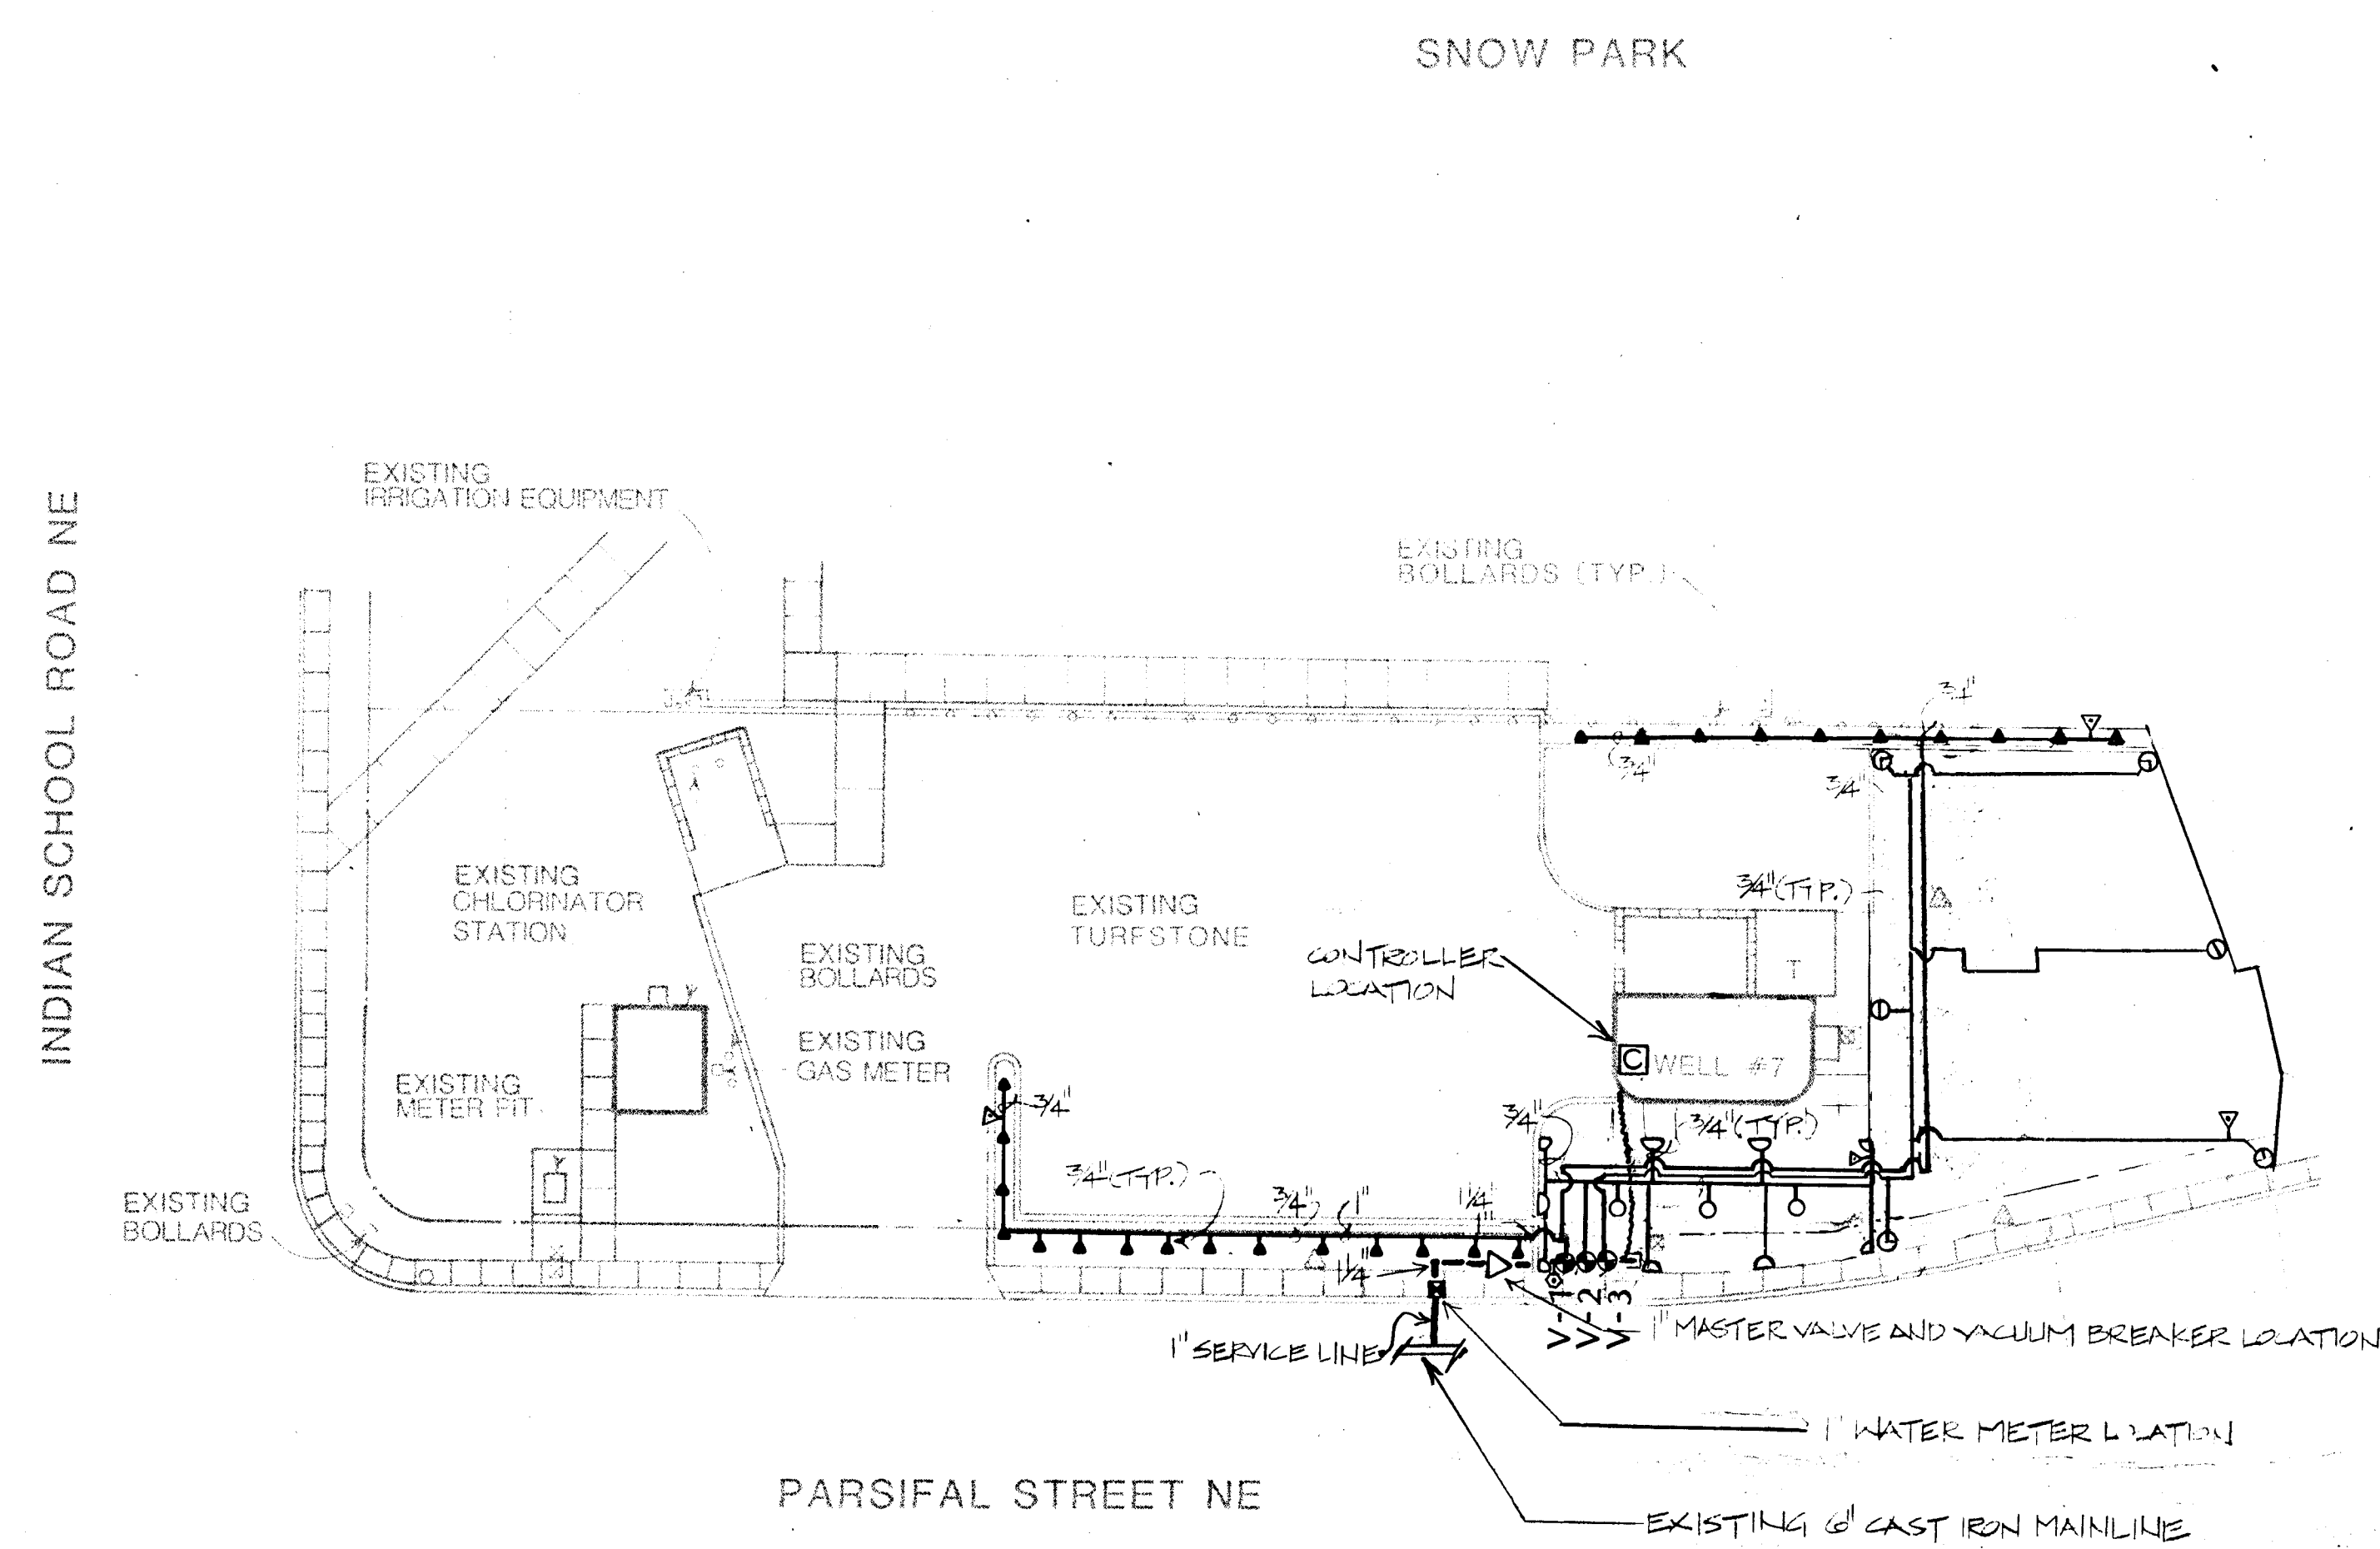

MORROW & COMPANY
LANDSCAPE ARCHITECTS
210 LA VELA DRIVE, SUITE 100
ALBUQUERQUE, NEW MEXICO 87108
505-268-2266



NOVEMBER
1986

AS BUILT


LOVE WELL #7
1815 PARSIFAL STREET NE
IRRIGATION PLAN

LANDSCAPING IMPROVEMENTS FOR
WATER SYSTEM FACILITY SITES
WATER SYSTEMS DIVISION
CLAYTON DISTRICT
ALBUQUERQUE, NEW MEXICO

SHEET
172

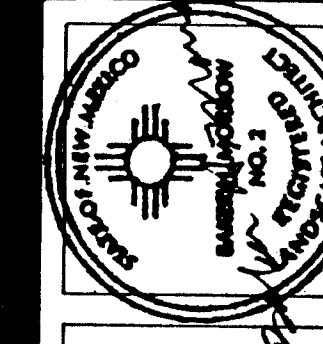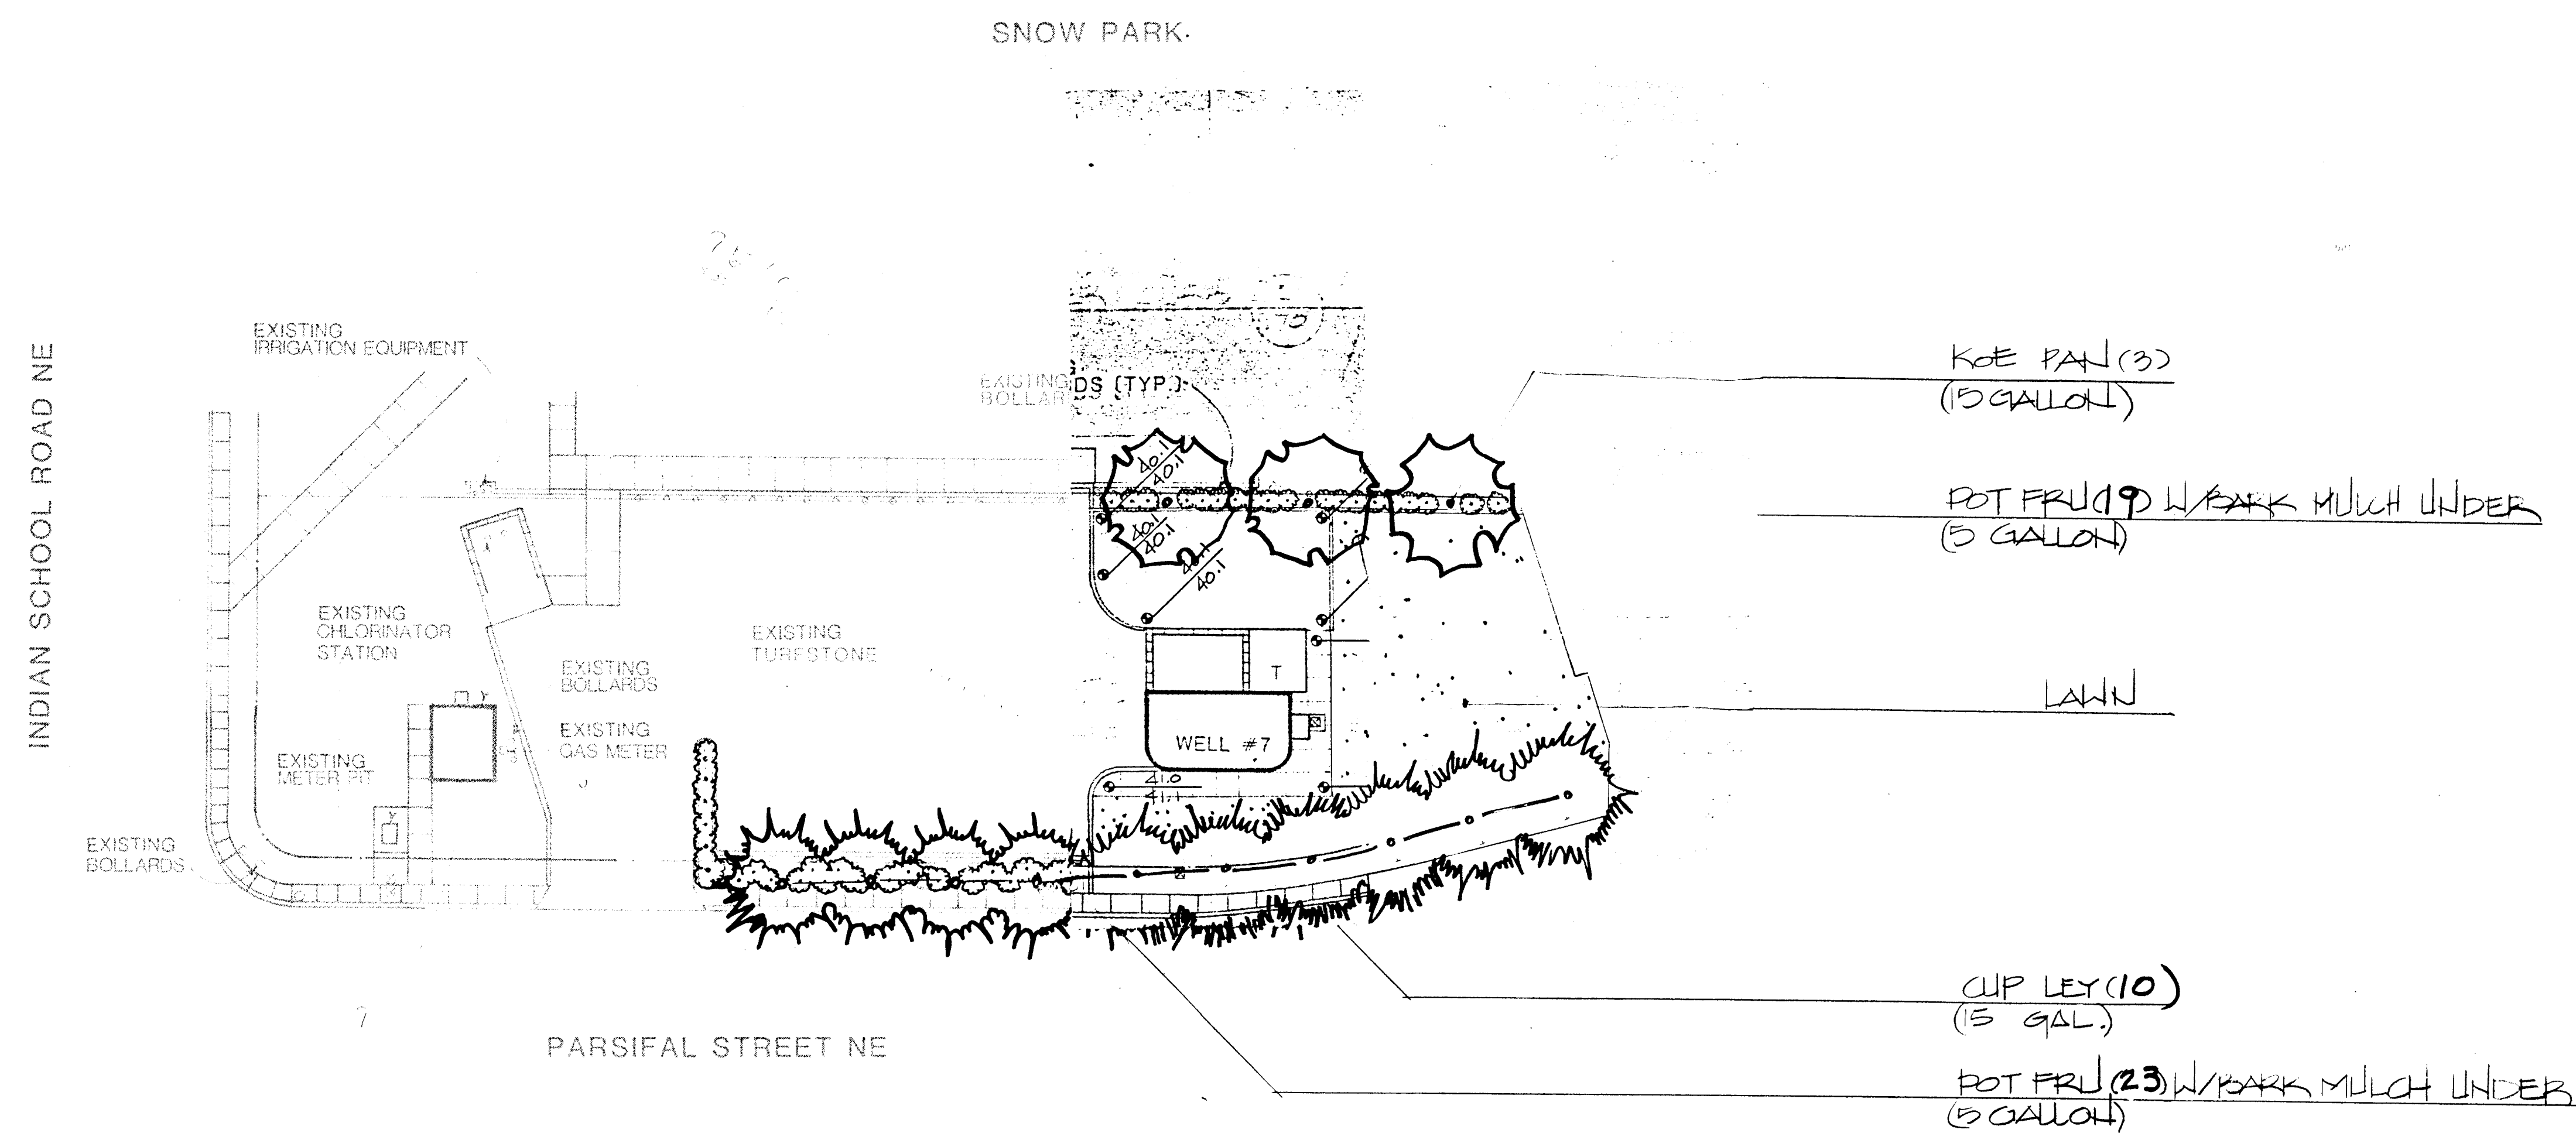

MORROW & COMPANY
LANDSCAPE ARCHITECTS
210 La Veta Drive NE
Albuquerque, New Mexico 87108
505-268-2266

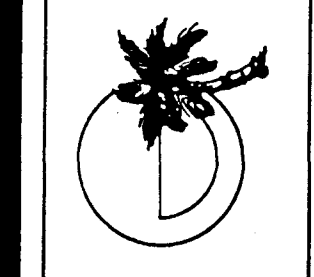

NOVEMBER
1986



AS BUILT

LOVE WELL #7
1815 PARSIFAL STREET NE
PLANTING PLAN

LANDSCAPING IMPROVEMENTS FOR
WATER SYSTEM FACILITY SITES
WATER SYSTEMS DIVISION
NEW MEXICO DEPARTMENT OF
ALBUQUERQUE, NEW MEXICO

SHEET
193
1/2


UNIVERSITY BLVD. SE

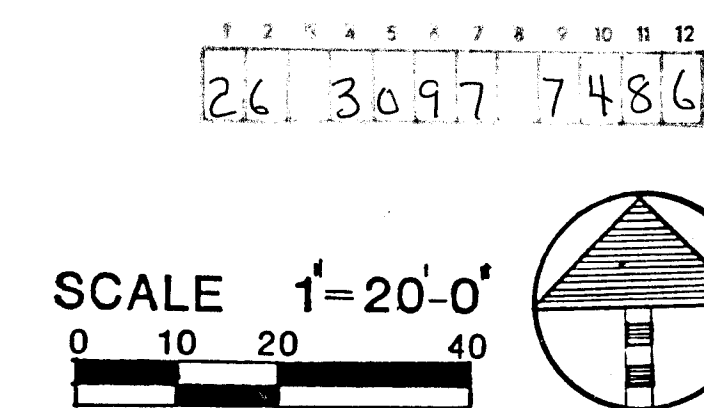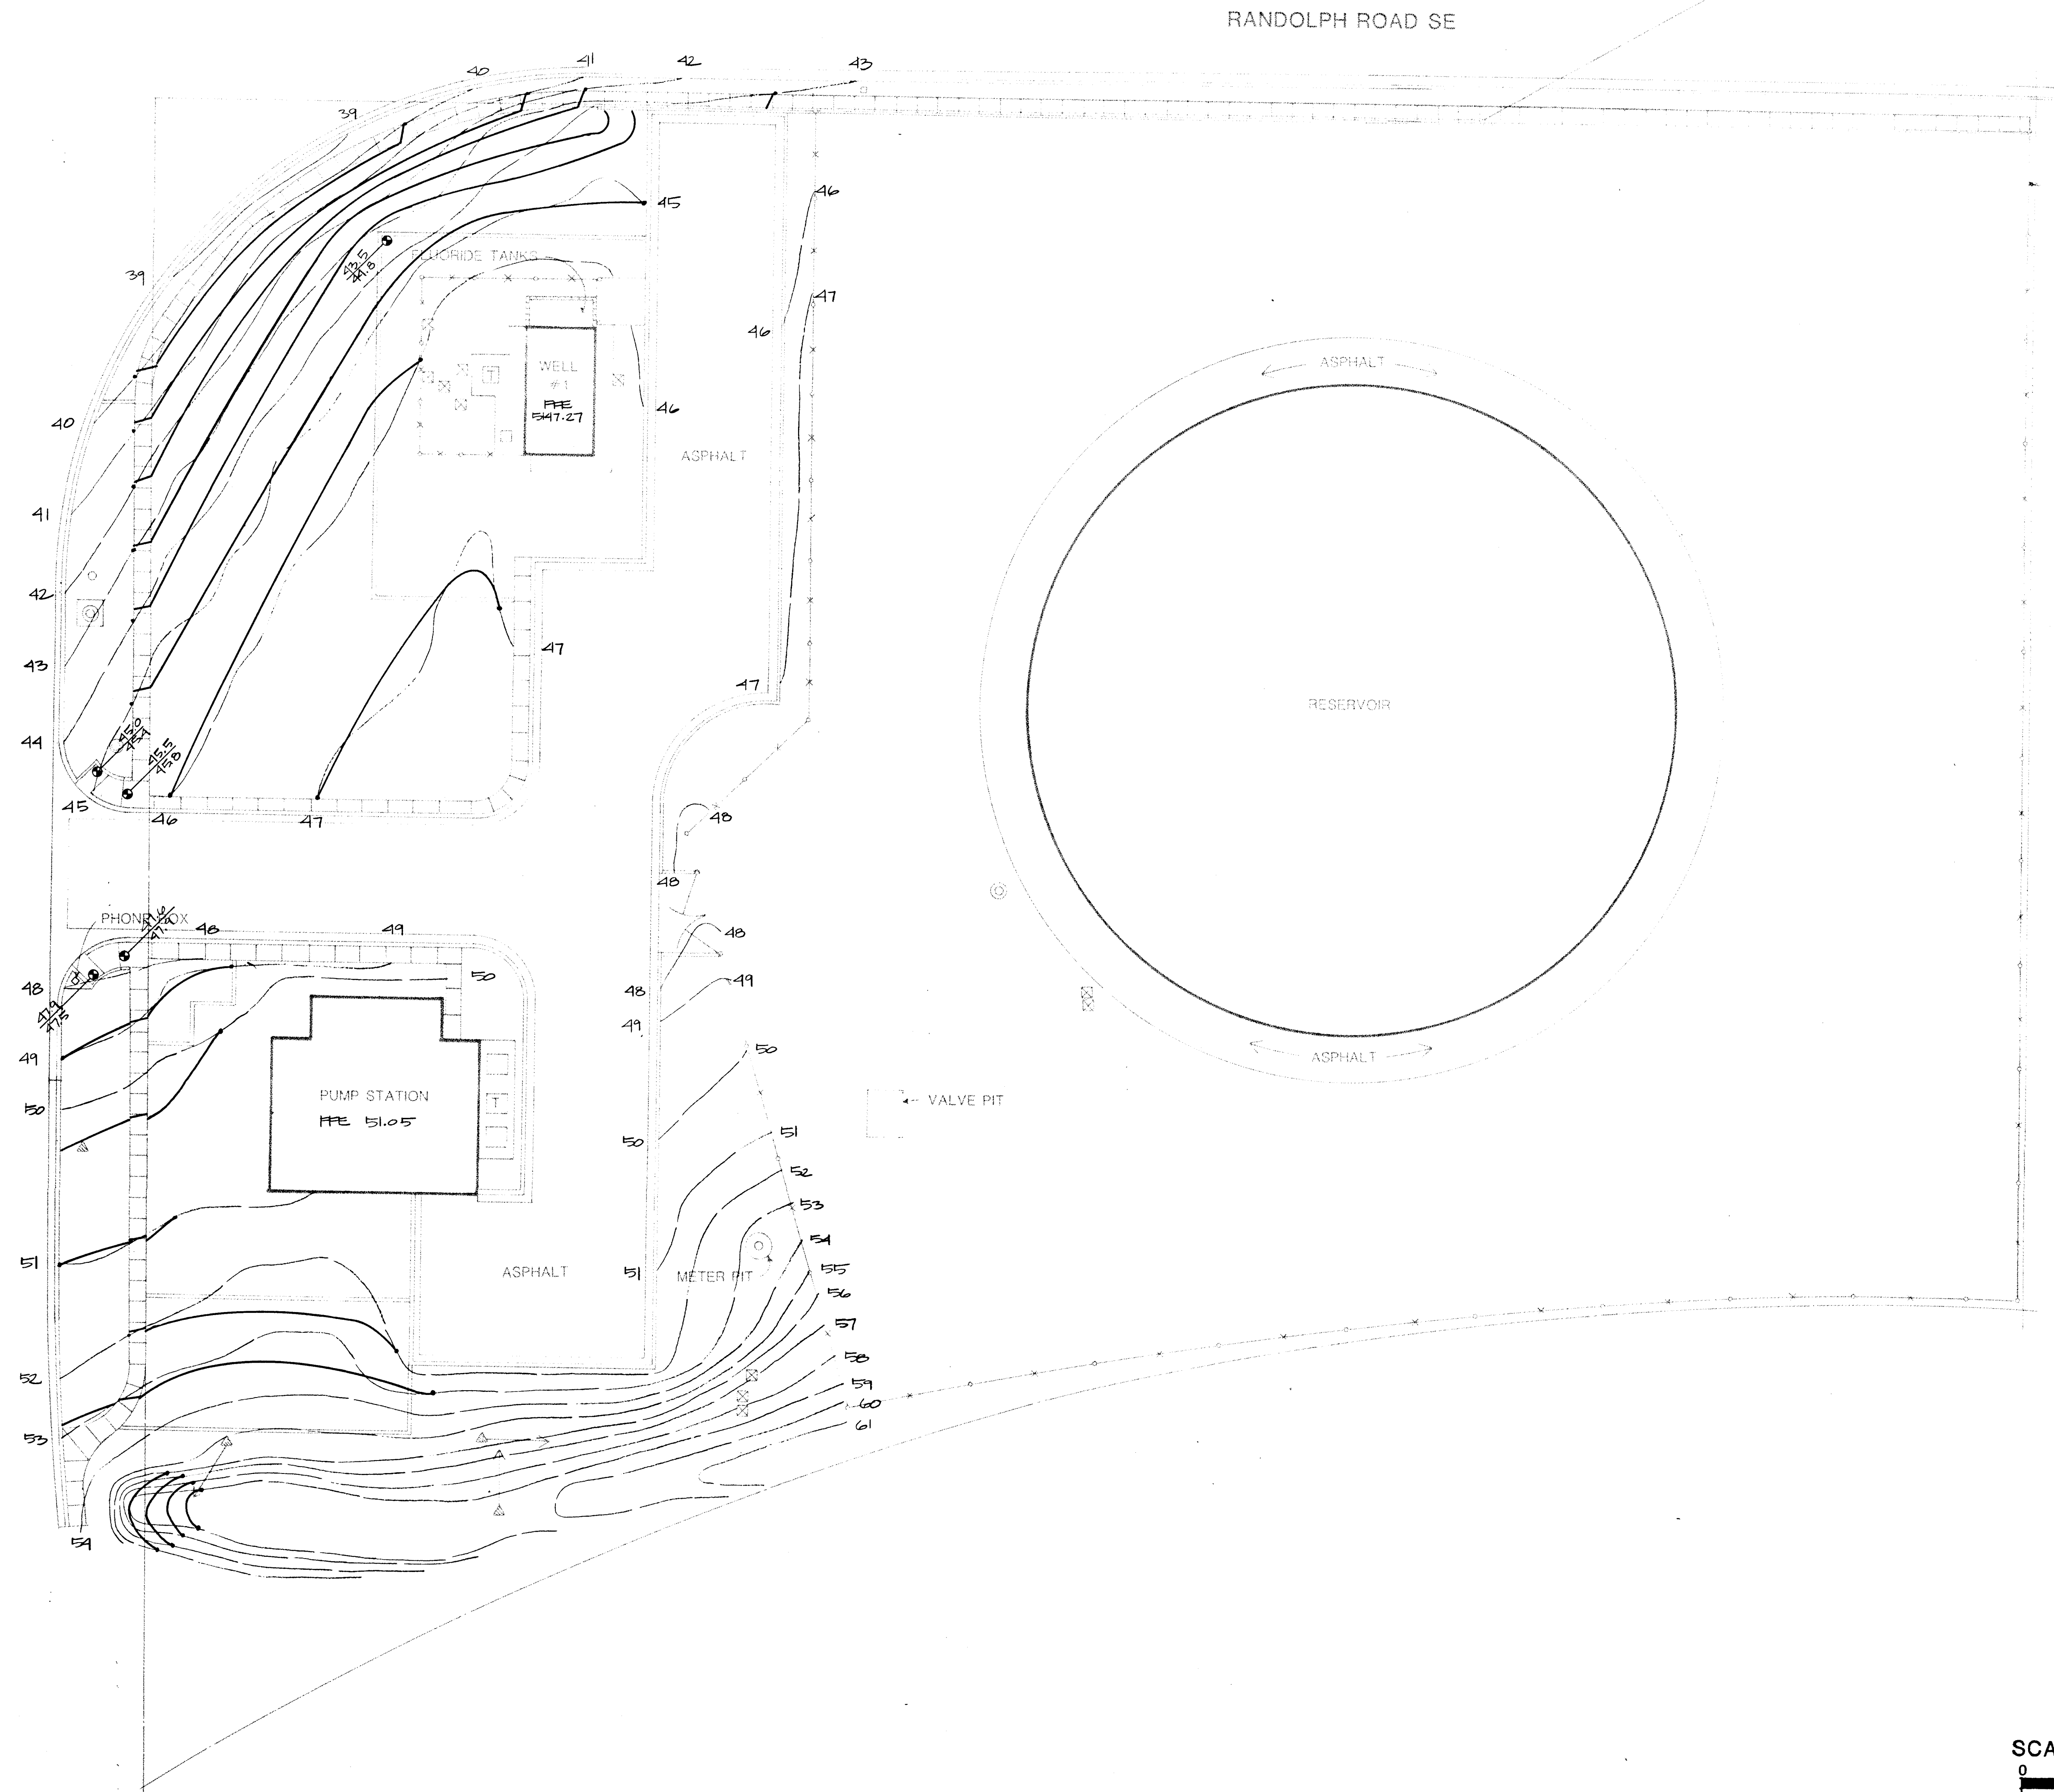

	LANDSCAPING IMPROVEMENTS FOR WATER SYSTEM FACILITY SITES WATER SYSTEMS DIVISION ALBUQUERQUE, NEW MEXICO
	SHEET 12

NOVEMBER 1986	AS BUILT
MILES WELL #1, RESERVOIR & PUMP STATION 3108 UNIVERSITY BLVD. SE GRADING PLAN	

	MORROW & COMPANY LANDSCAPE ARCHITECTS 210 La Vista Drive NE Albuquerque, New Mexico 87108 505-268-2266
--	--

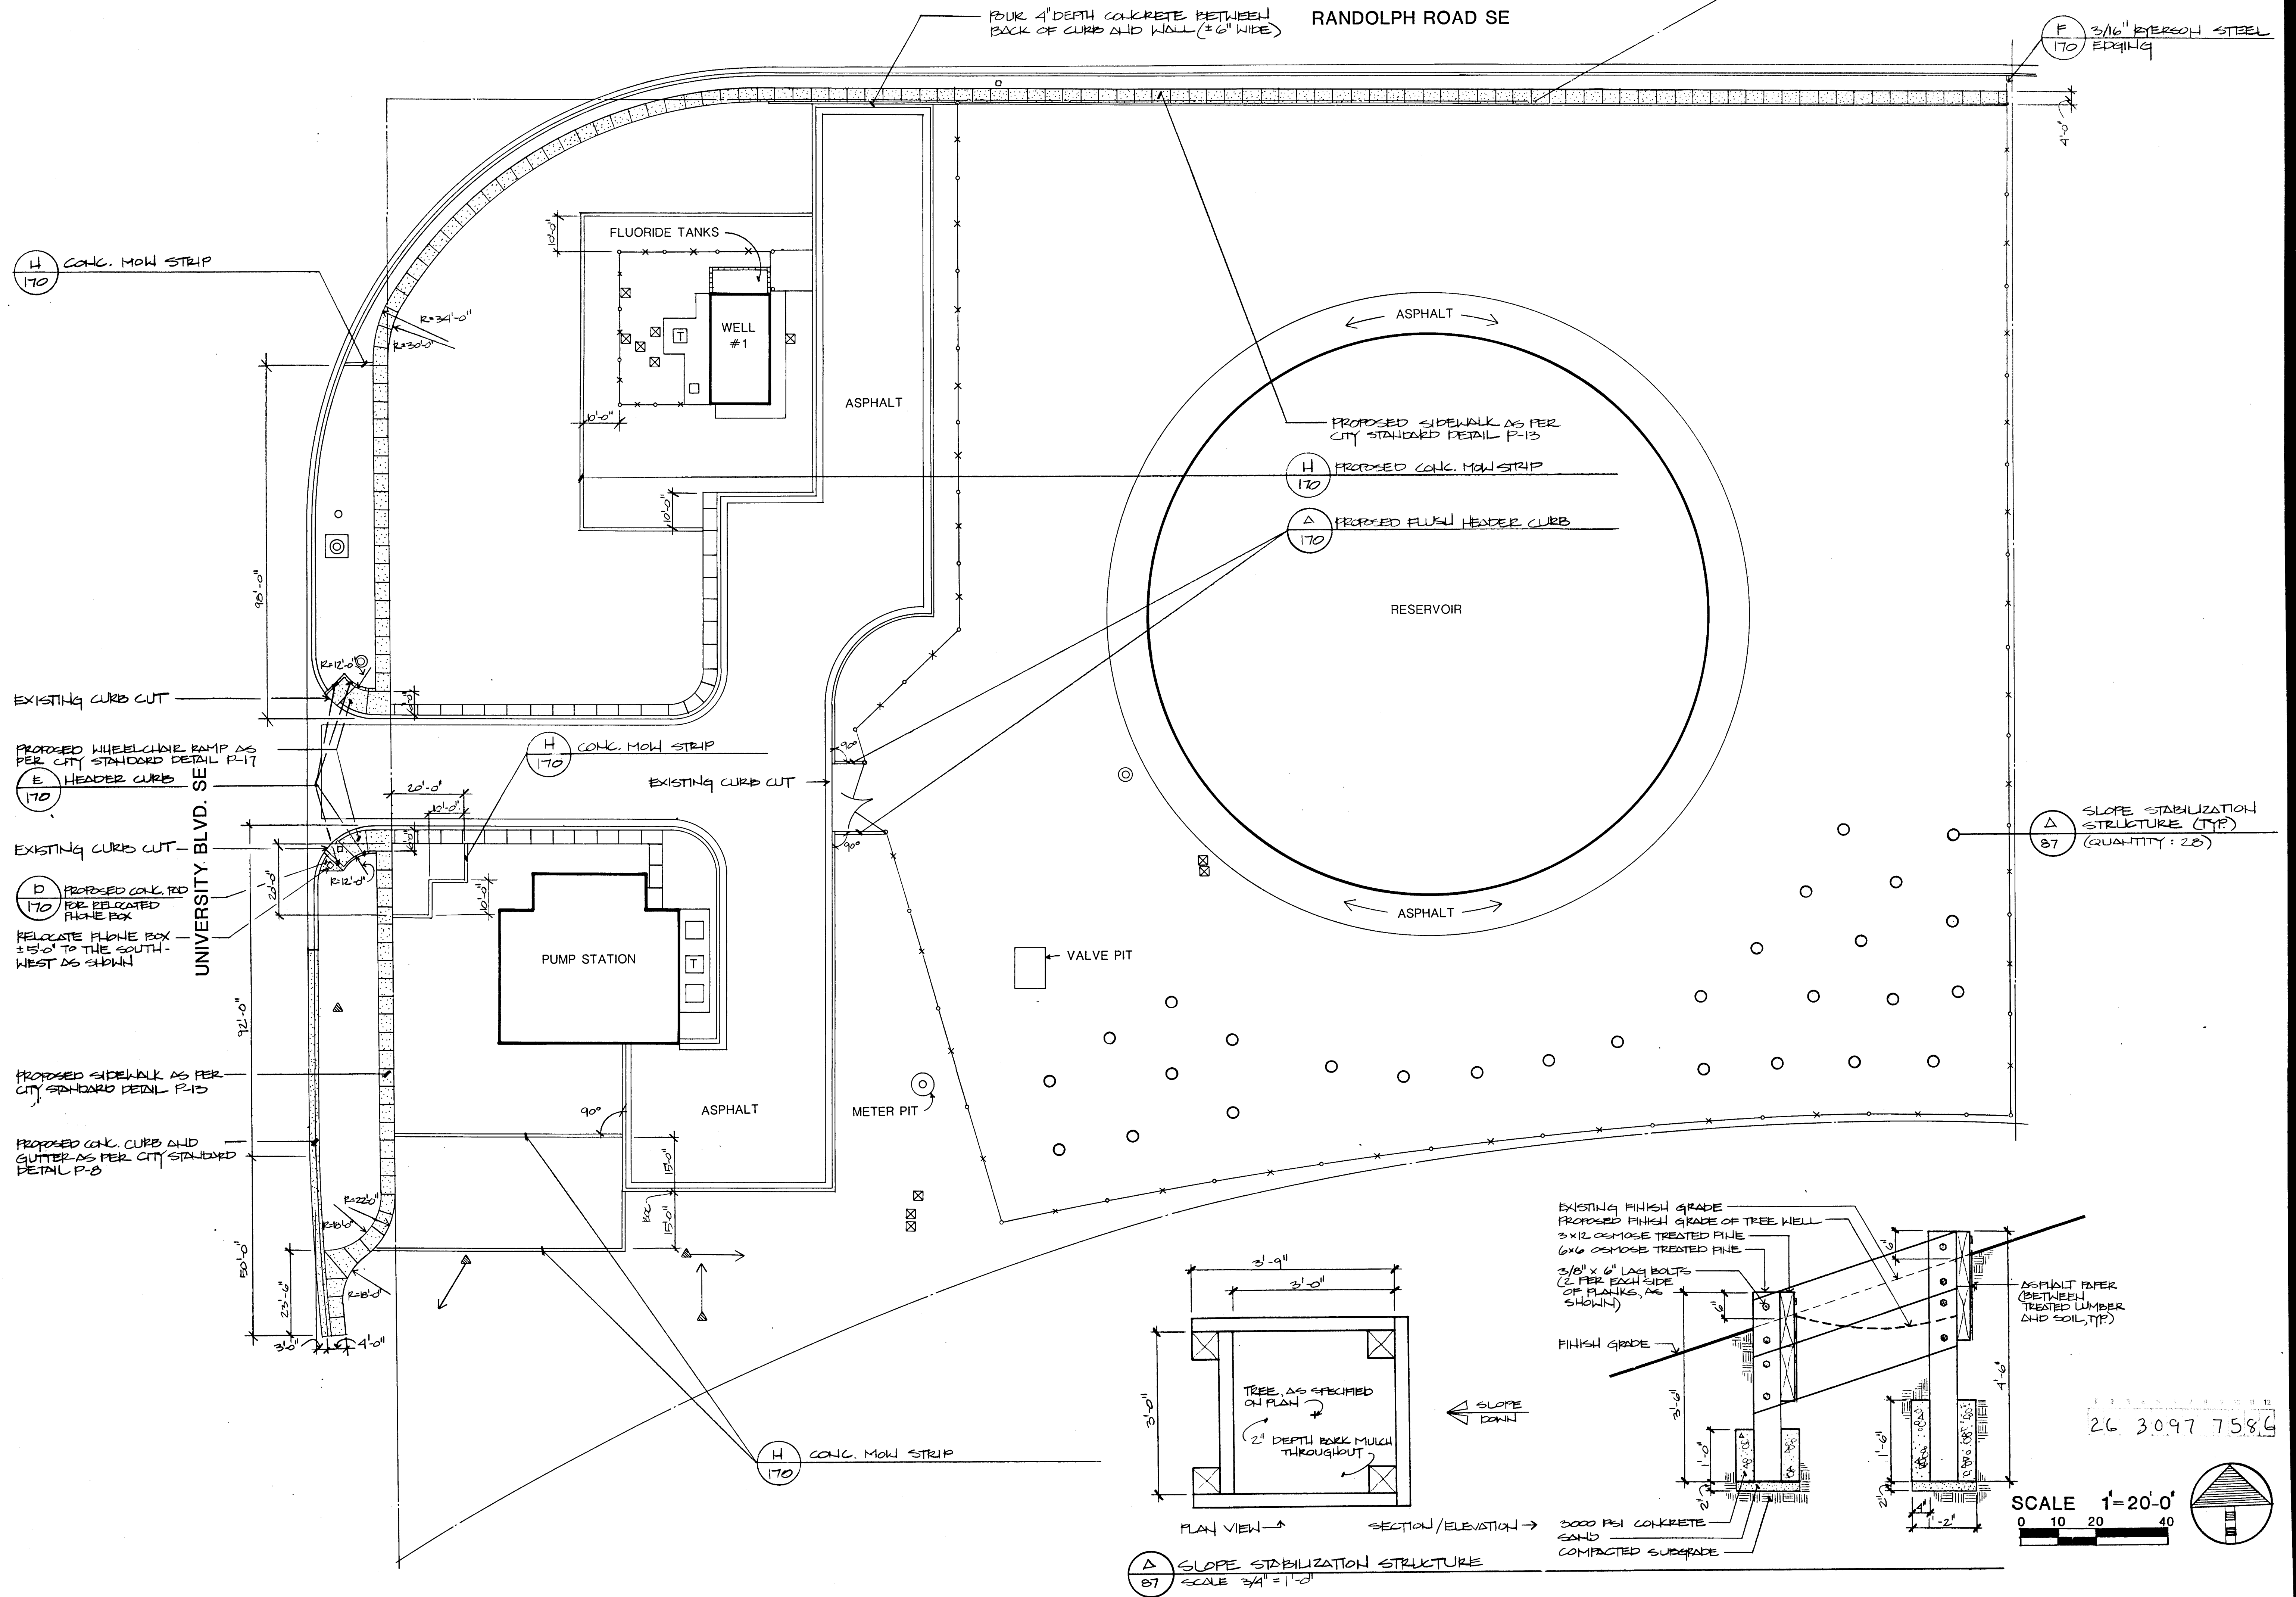

MORROW & COMPANY
LANDSCAPE ARCHITECTS
210 La Veta Drive NE
Albuquerque, New Mexico 87108
505-268-2266

NOVEMBER
1986


MILES WELL #1, RESERVOIR & PUMP STATION
3108 UNIVERSITY BLVD. SE
CONSTRUCTION PLAN

LANDSCAPING IMPROVEMENTS FOR
WATER SYSTEM FACILITY SITES
WATER SYSTEMS DIVISION
CITY OF ALBUQUERQUE
ALBUQUERQUE, NEW MEXICO

SHEET
87
OF
172

UNIVERSITY BLVD. SE

RANDOLPH ROAD SE

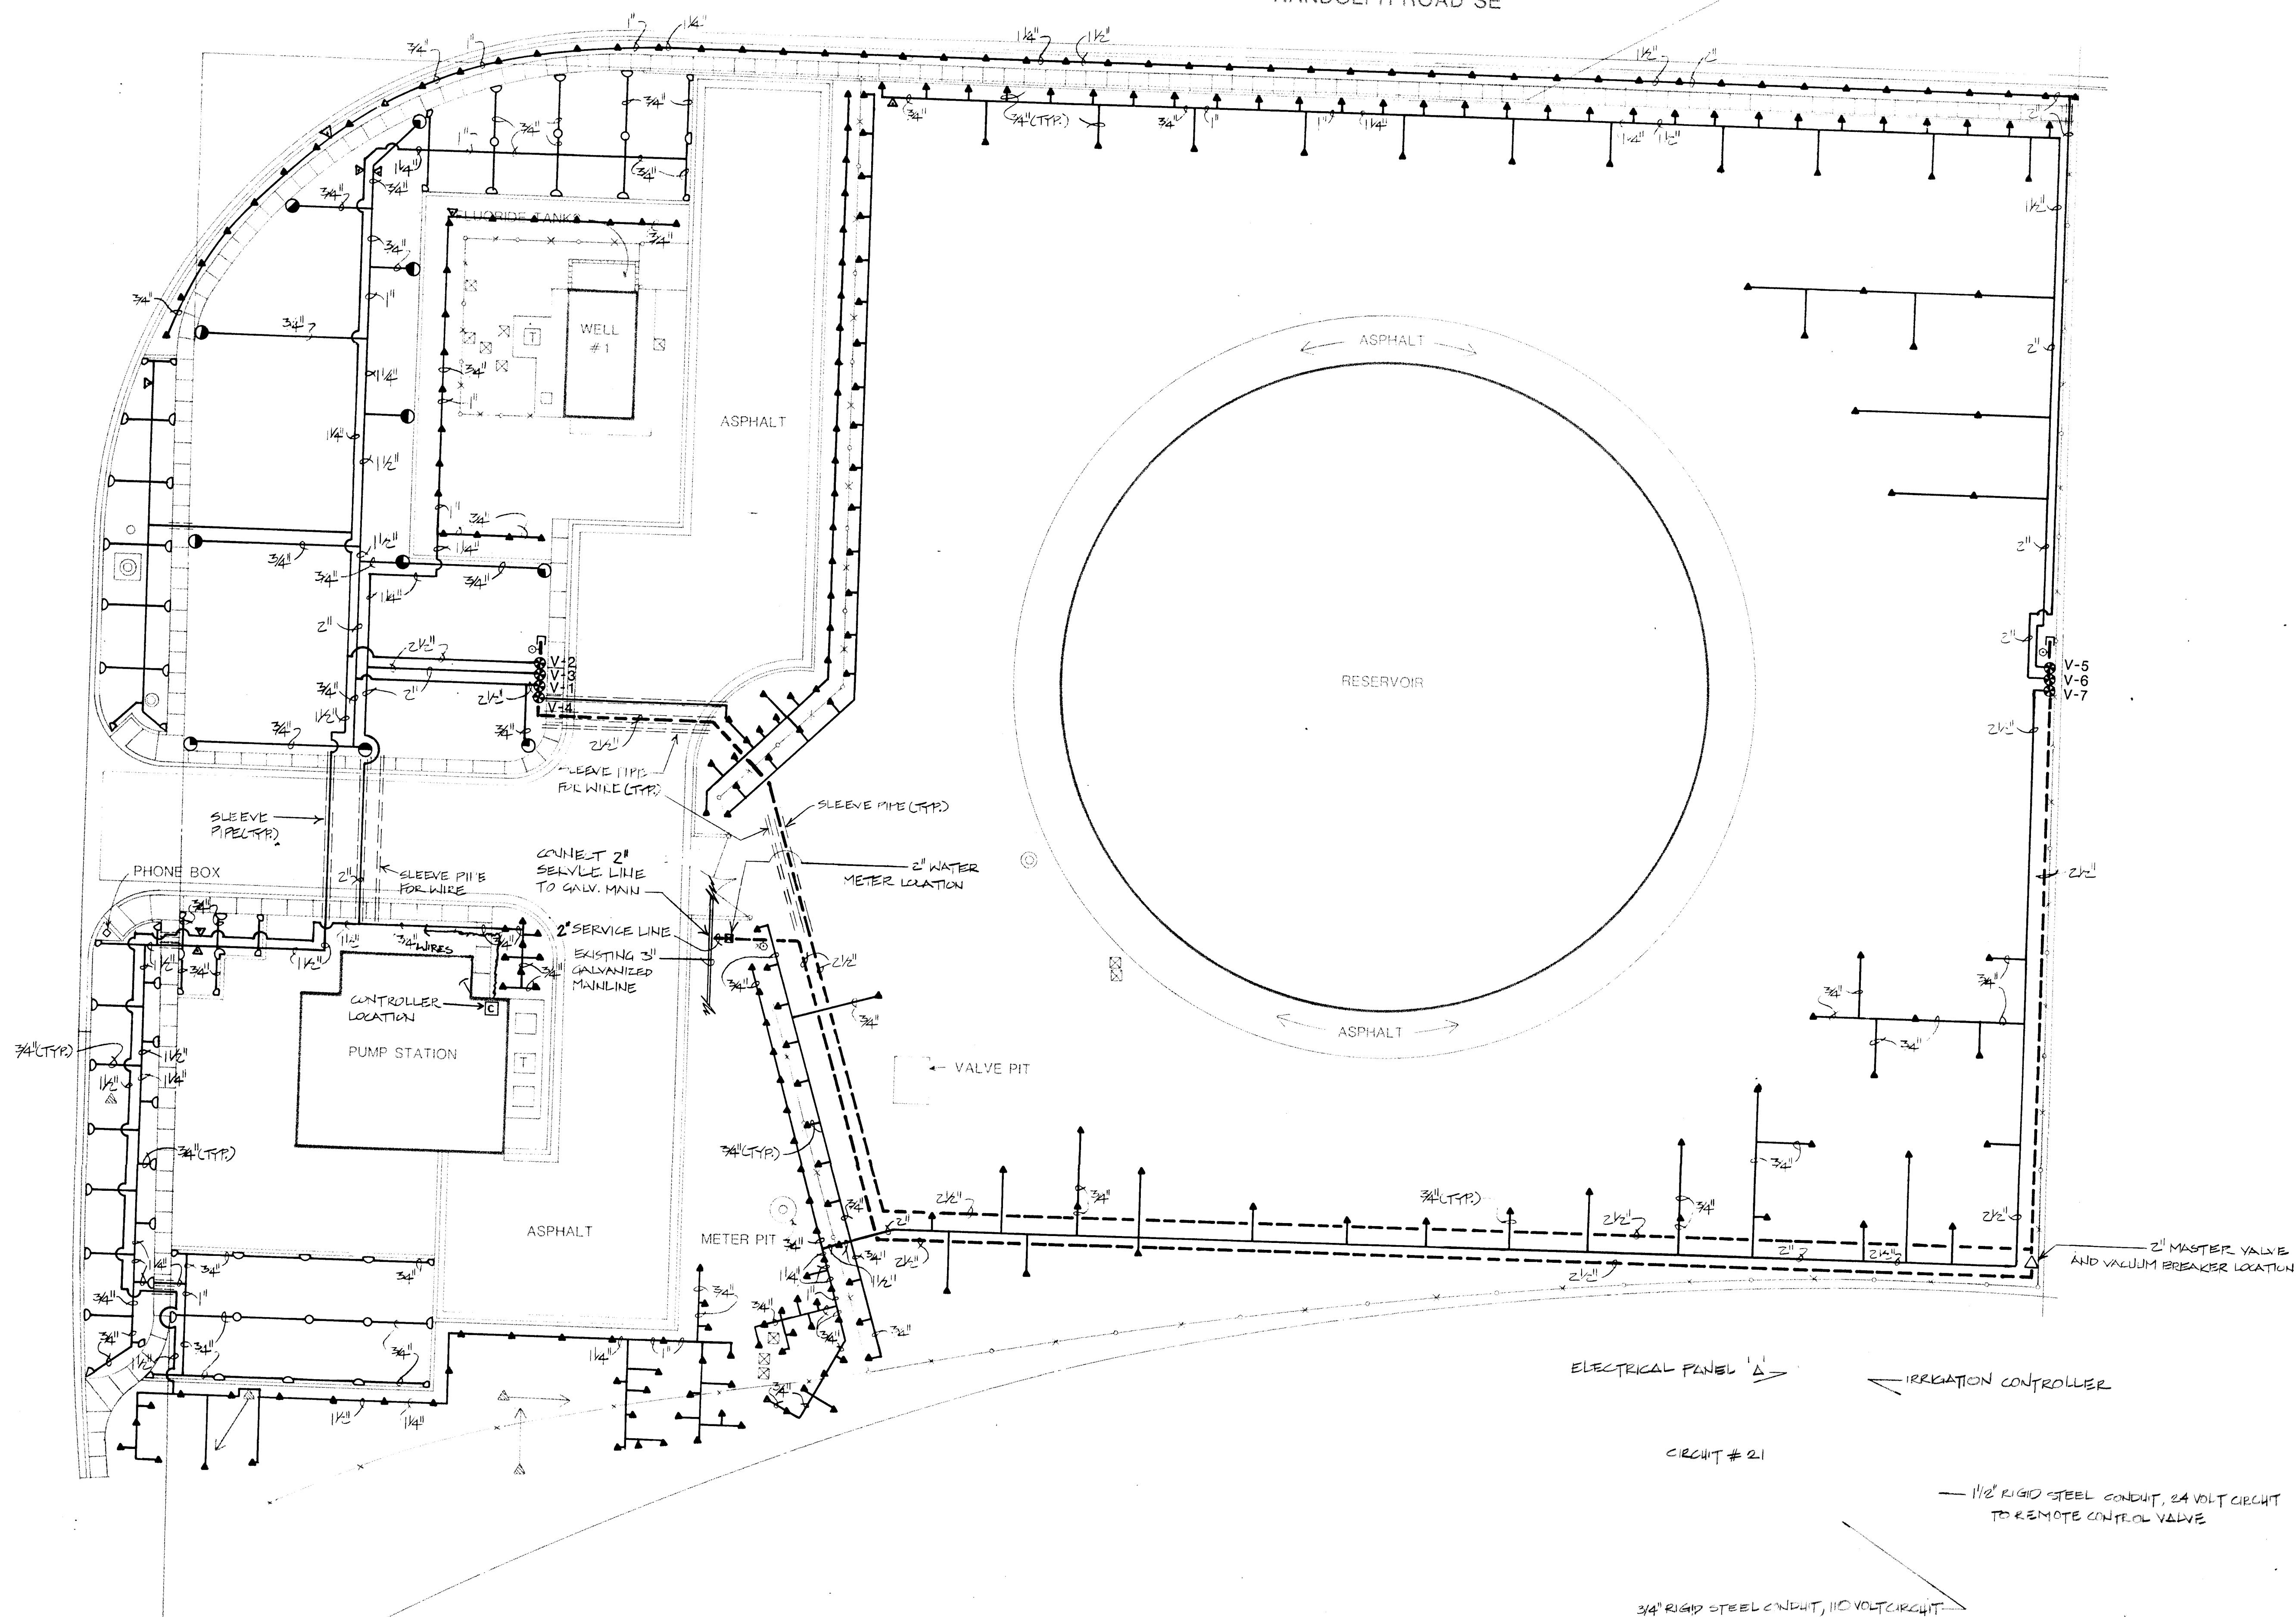

ELECTRICAL PANEL

IRRIGATION CONTROLLER


CIRCUIT # 21

1/2\"/>

3/4\"/>

SCHEMATIC AS BUILT FOR 110VOLT ELECTRICAL
FROM SOURCE TO IRRIGATION CONTROLLER

SCALE 1\"/>

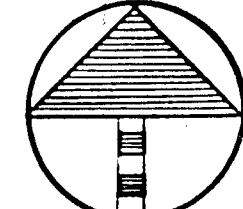


LANDSCAPING IMPROVEMENTS FOR
WATER SYSTEM FACILITY SITES
WATER SYSTEMS DIVISION
CITY OF ALBUQUERQUE
ALBUQUERQUE, NEW MEXICO


MILES WELL #1, RESERVOIR & PUMP STATION
3108 UNIVERSITY BLVD. SE
IRRIGATION PLAN


NOVEMBER
1986

MORROW & COMPANY
LANDSCAPE ARCHITECTS
210 La Veta Drive NE
Albuquerque, New Mexico 87108
505-268-2266

SHEET
88
172

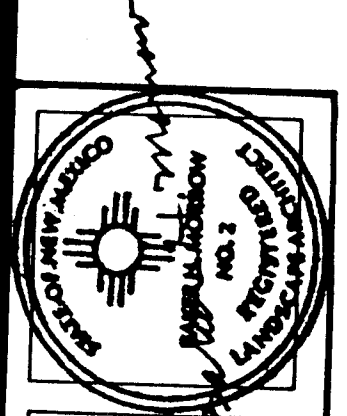

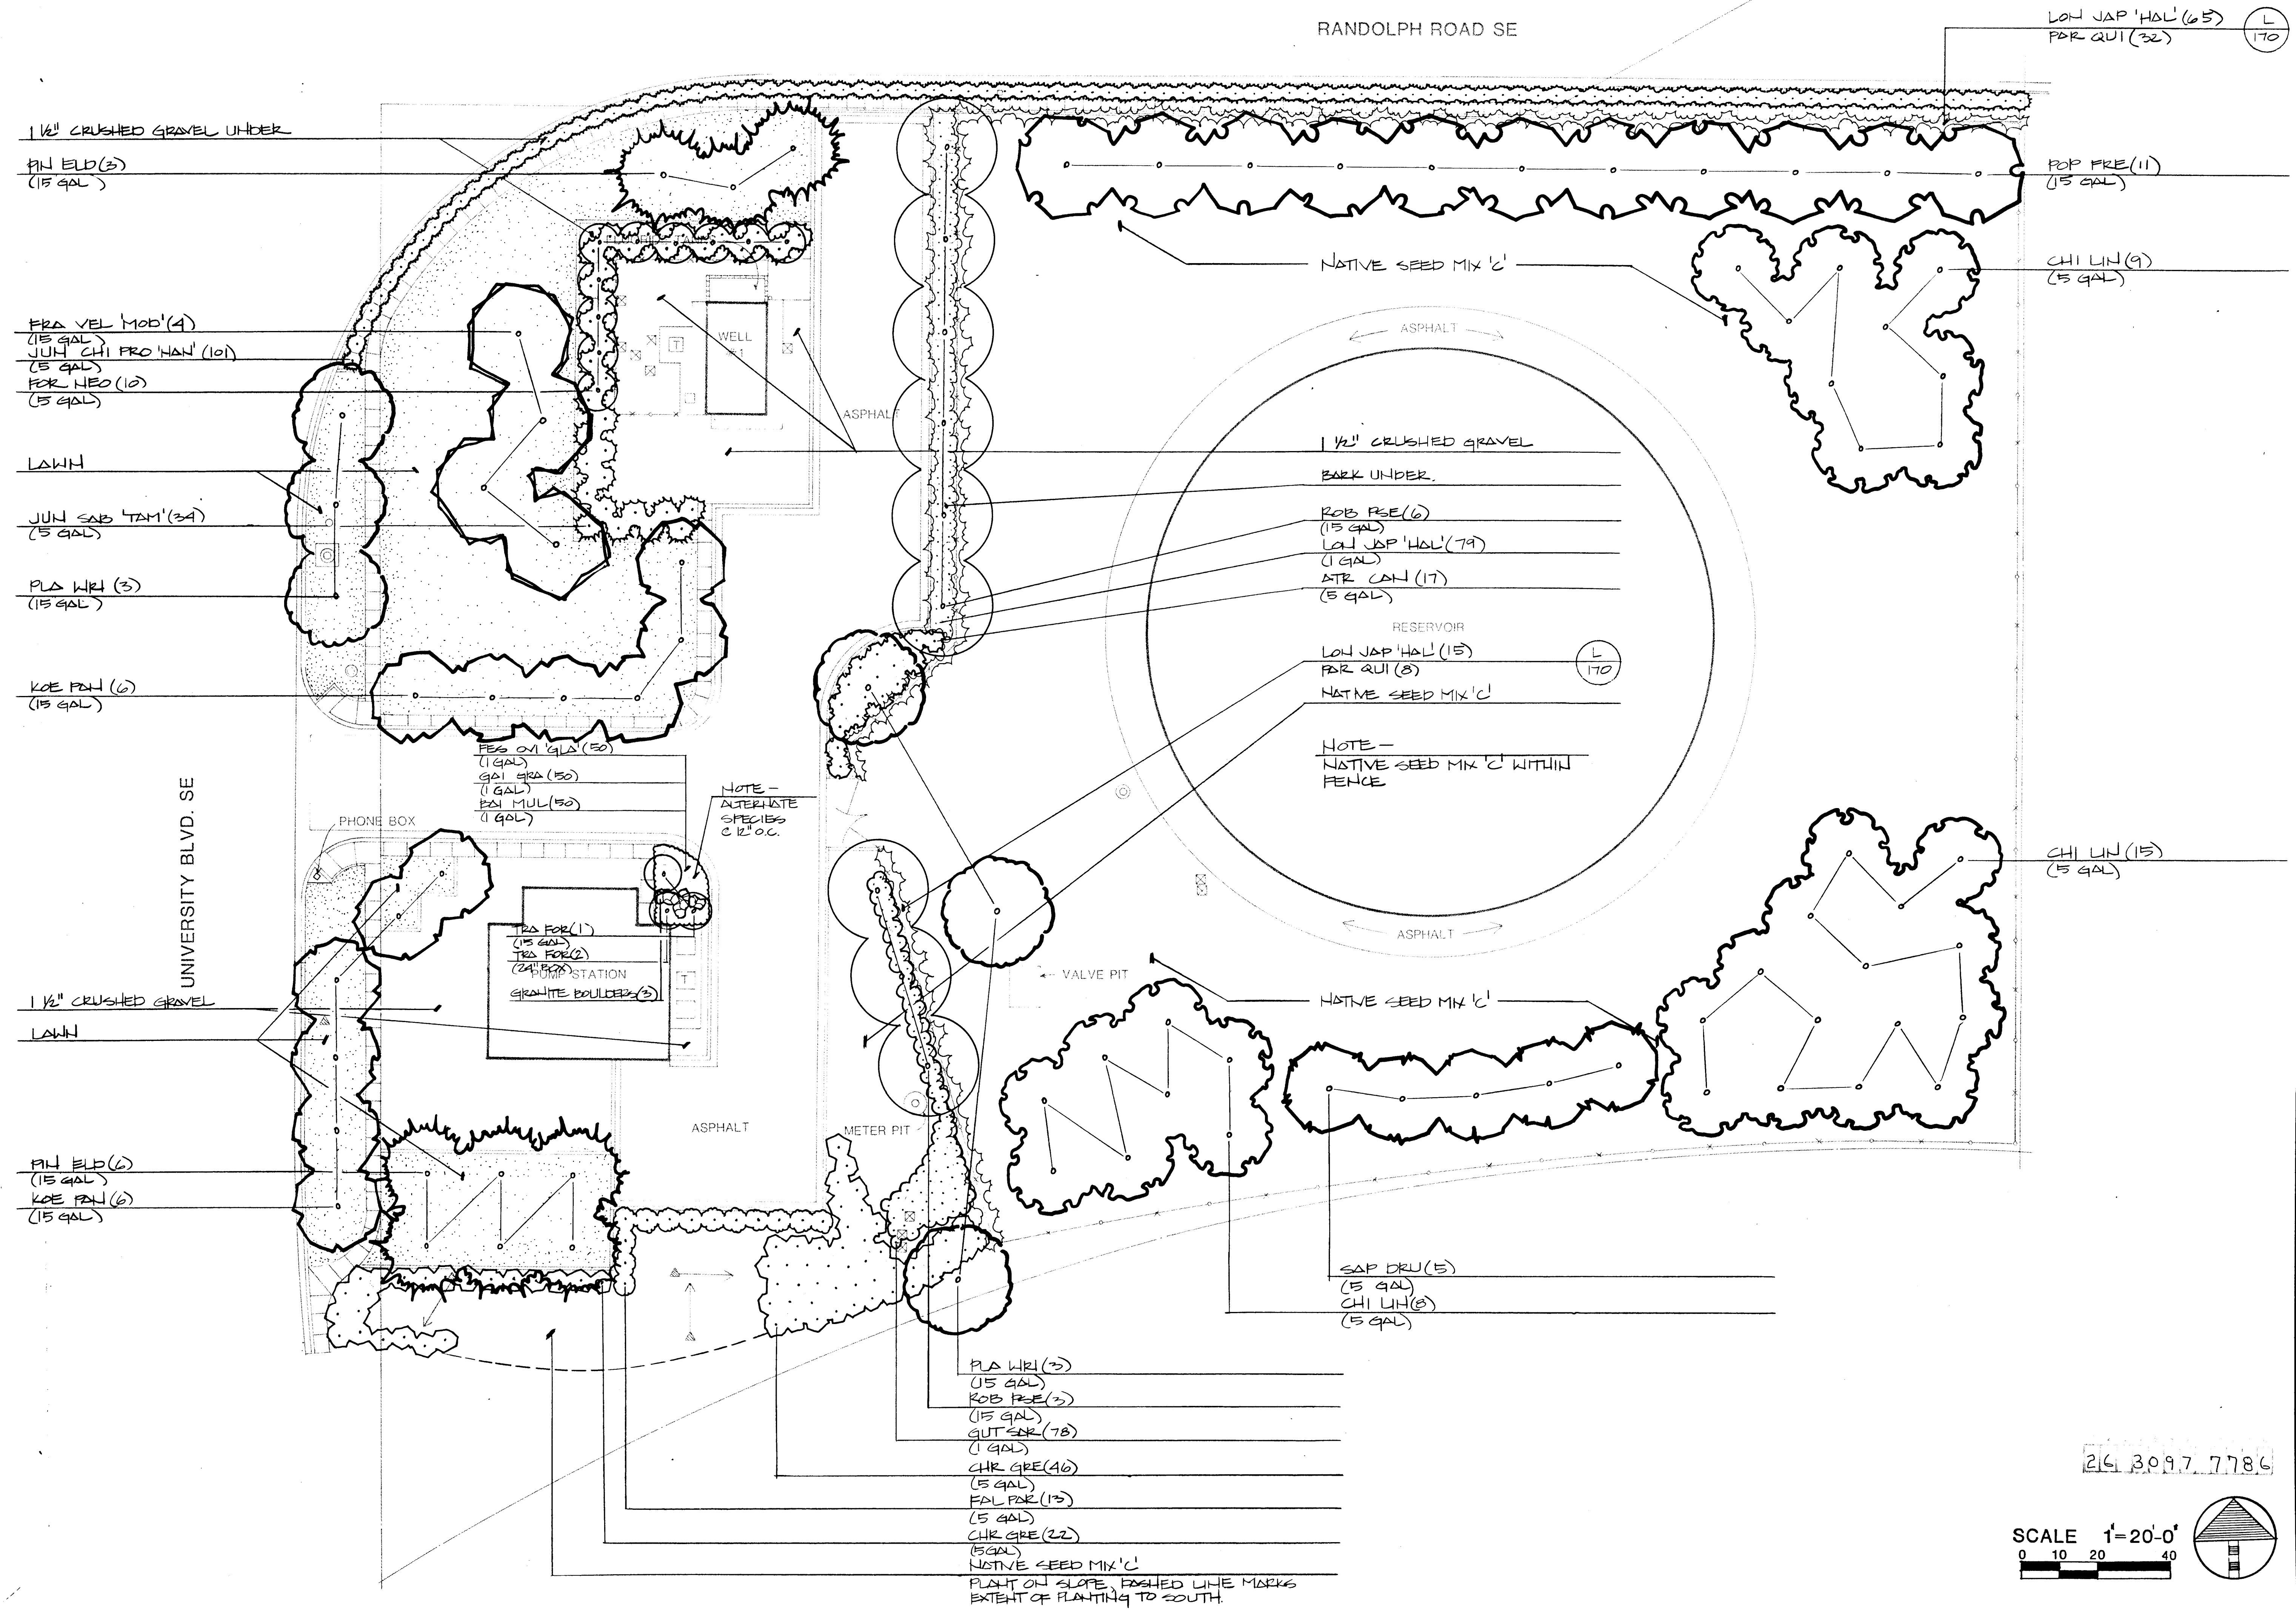

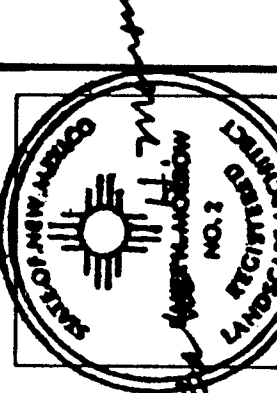

MORROW & COMPANY
LANDSCAPE ARCHITECTS
210 La Veta Drive NE
Albuquerque, New Mexico 87108
505-268-2266

NOVEMBER 1986

MILES WELL #1, RESERVOIR & PUMP STATION

3108 UNIVERSITY BLVD. SE

AS BUILT

PLANTING PLAN

LANDSCAPING IMPROVEMENTS FOR

WATER SYSTEM FACILITY SITES

WATER SYSTEMS DIVISION


CITY OF ALBUQUERQUE

ALBUQUERQUE, NEW MEXICO

26 3097 7786


SCALE 1"=20'-0"

0 10 20 40

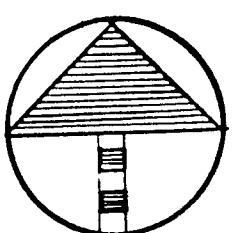


SHEET

172

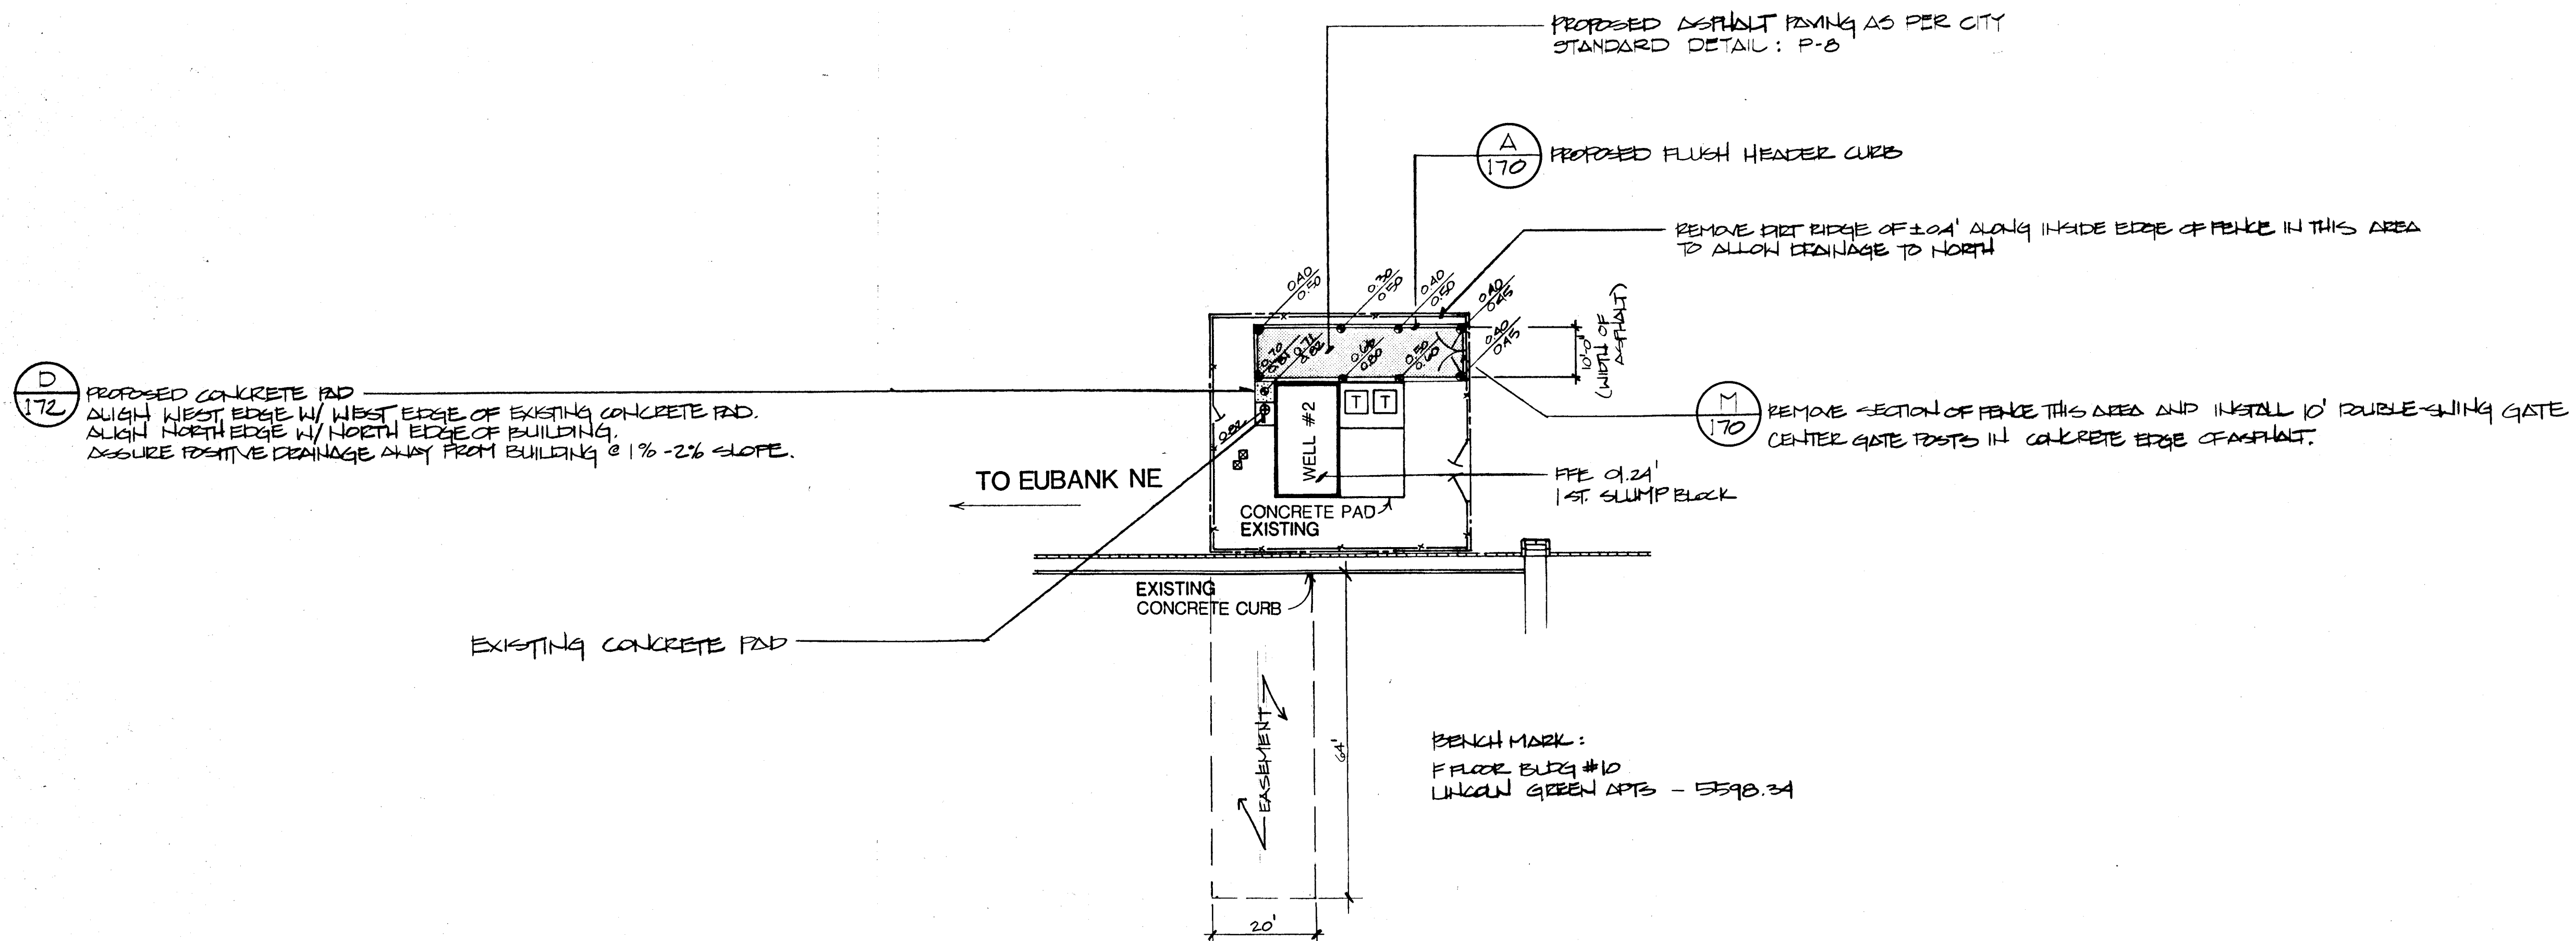

SCALE 1"=20'-0"

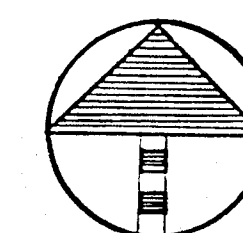

26 3097 7886


SHEET
172

LANDSCAPING IMPROVEMENTS FOR
WATER SYSTEM FACILITY SITES
WATER SYSTEMS DIVISION
CITY OF ALBUQUERQUE
ALBUQUERQUE, NEW MEXICO

PONDEROSA WELL #2
4620 EUBANK NE


AS BUILT
GRADING & CONSTRUCTION PLAN

NOVEMBER
1986

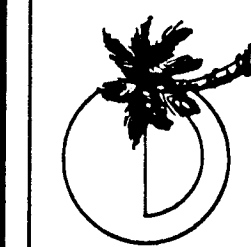

MORROW & COMPANY
LANDSCAPE ARCHITECTS
210 La Veta Drive NE
Albuquerque, New Mexico 87108
505-268-2266




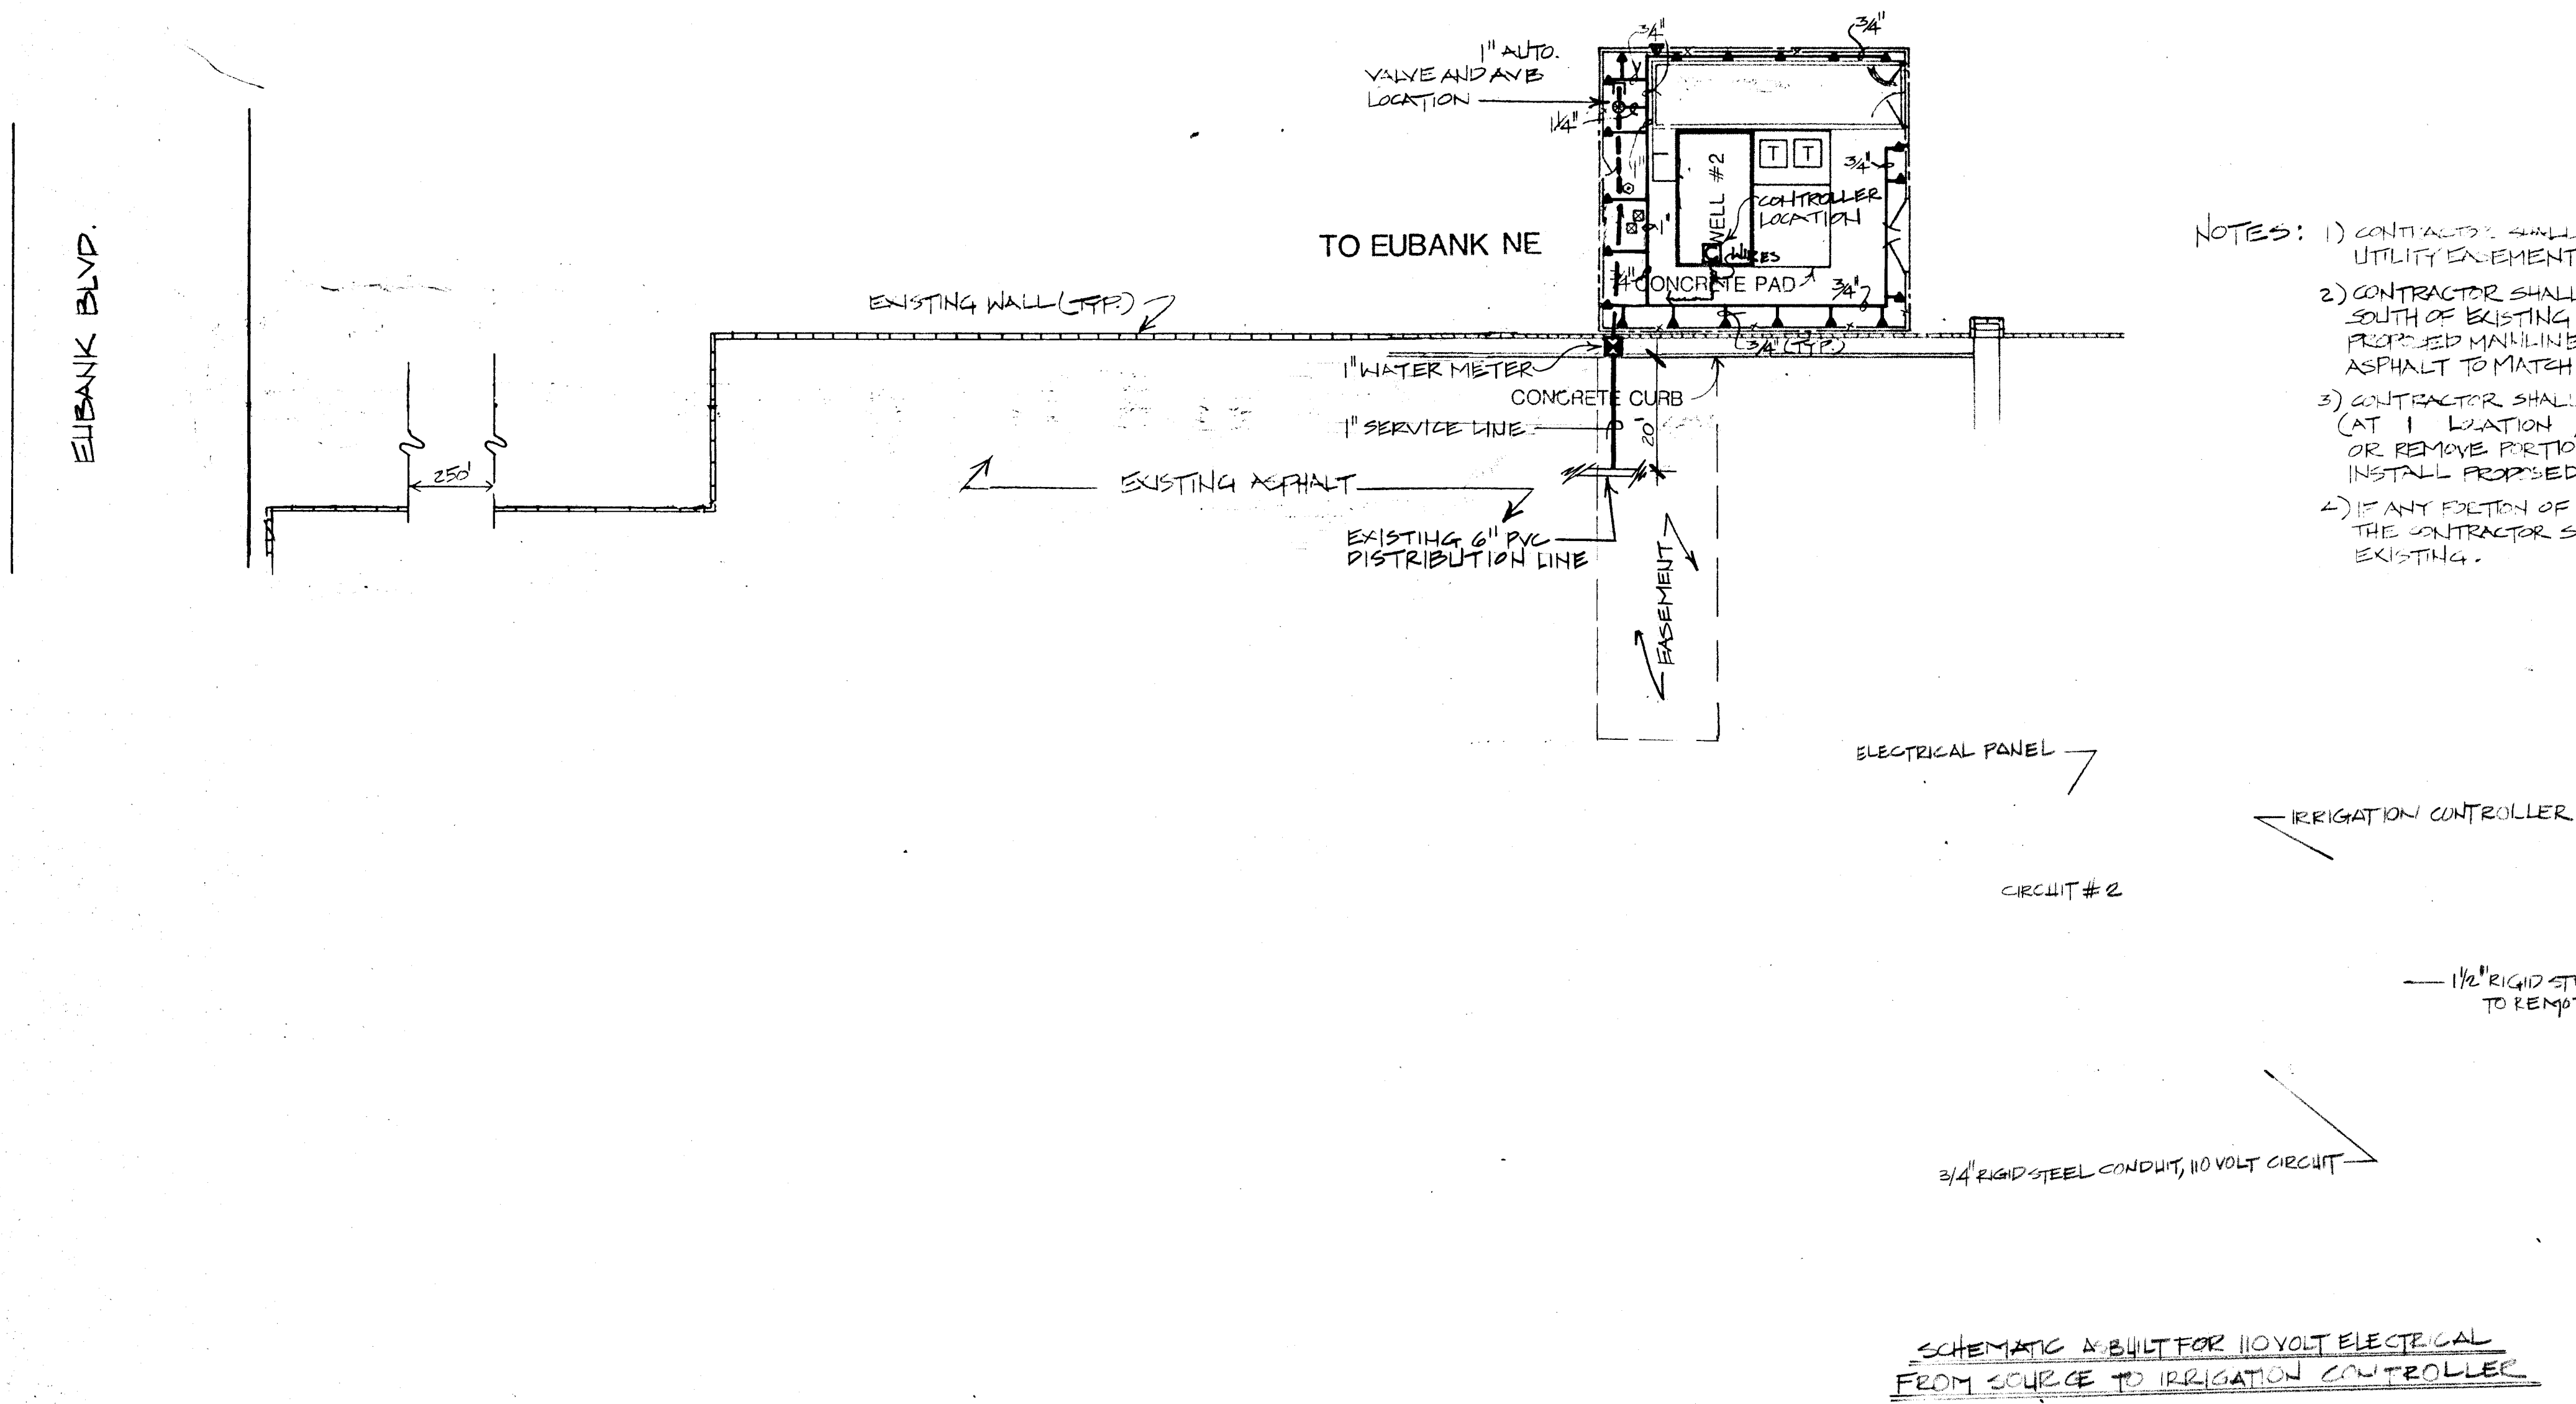

- NOTES:
- 1) CONTRACTOR SHALL INSTALL PROPOSED MAINLINE IN UTILITY EXEMPT AS SHOWN ON PLAN.
 - 2) CONTRACTOR SHALL SAW-CUT EXISTING ASPHALT SOUTH OF EXISTING WALL PRIOR TO INSTALLING PROPOSED MAINLINE AND REPLACE WITH NEW ASPHALT TO MATCH EXISTING.
 - 3) CONTRACTOR SHALL PATCH UNDER EXISTING WALL (AT 1" LOCATION, SEE PLAN) OR REMOVE PORTION OF WALL AS NEEDED TO INSTALL PROPOSED MAINLINE.
 - 4) IF ANY PORTION OF EXISTING WALL IS REMOVED, THE CONTRACTOR SHALL REPLACE WALL TO MATCH EXISTING.

SCALE 1"=20'-0"

0 10 20 40

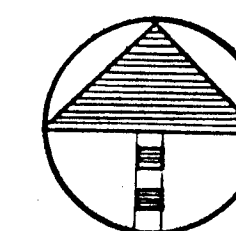

26 3097 7986

SHEET
172


LANDSCAPING IMPROVEMENTS FOR
WATER SYSTEM FACILITY SITES
WATER SYSTEMS DIVISION
CITY OF ALBUQUERQUE
ALBUQUERQUE, NEW MEXICO


PONDEROSA WELL #2
4620 EUBANK NE
IRRIGATION PLAN

AS BUILT


NOVEMBER
1986

MORROW & COMPANY
LANDSCAPE ARCHITECTS
210 La Veta Drive NE
Albuquerque, New Mexico 87108
505-268-2266

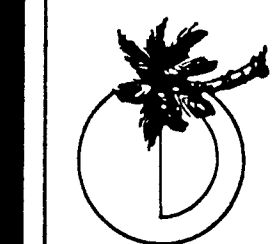

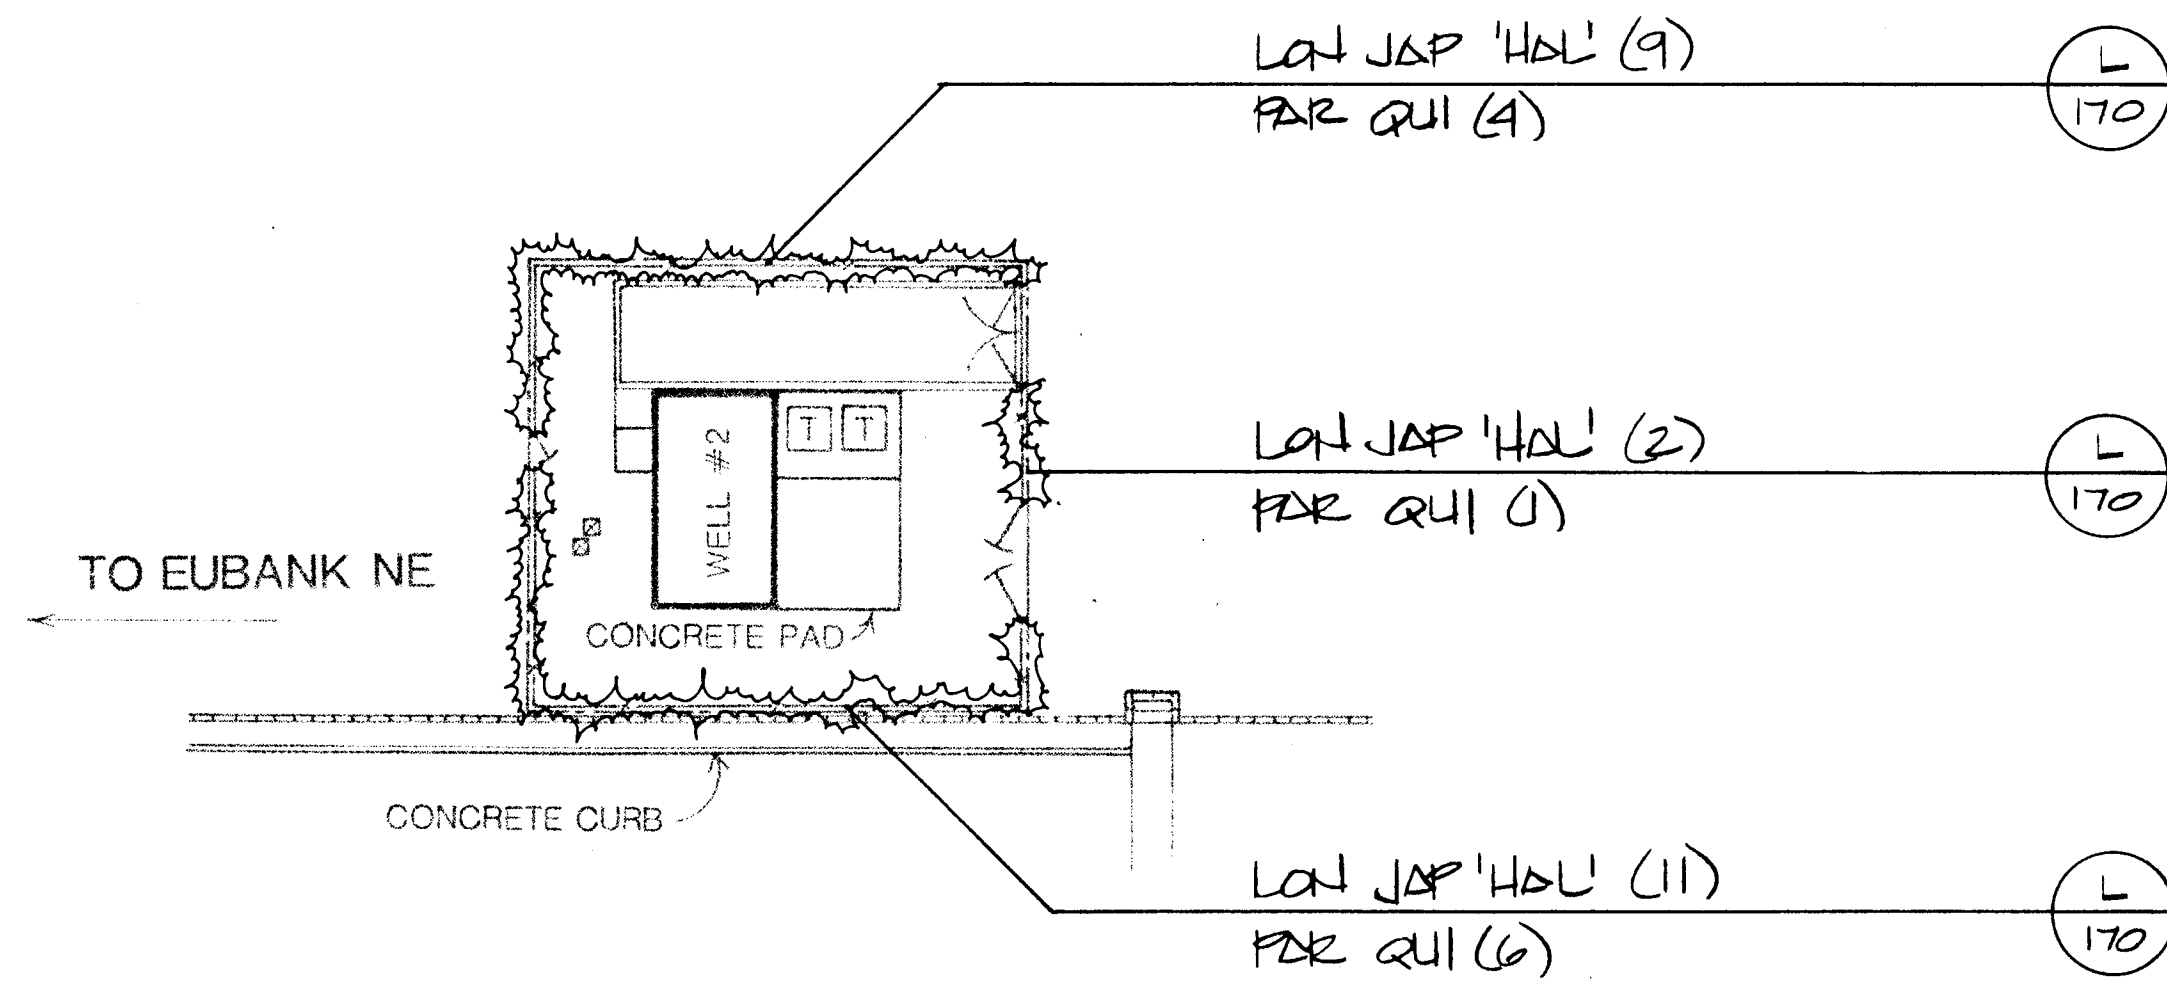

SCALE 1"=20'-0"

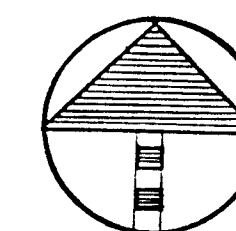

26 3097 8086


SHEET
10 of 12

LANDSCAPING IMPROVEMENTS FOR
WATER SYSTEM FACILITY SITES
WATER SYSTEMS DIVISION
CITY OF ALBUQUERQUE
ALBUQUERQUE, NEW MEXICO


PONDEROSA WELL #2
4620 EUBANK NE
PLANTING PLAN


AS BUILT

NOVEMBER
1986

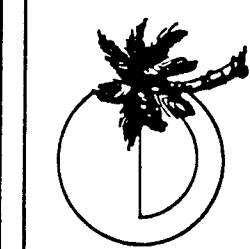


MORROW & COMPANY
LANDSCAPE ARCHITECTS
210 La Veta Drive NE
Albuquerque, New Mexico 87108
505-268-2266

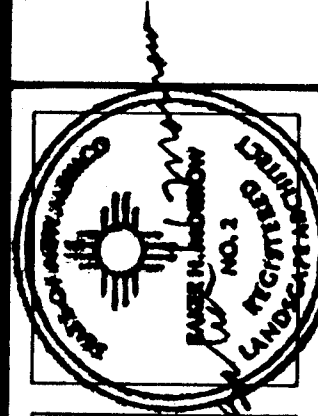


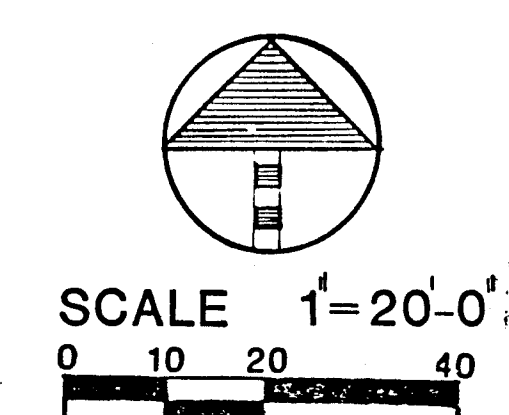
$$-TBM = 24.63 \text{ TC}$$
$$24.03 \text{ FL}$$


26 3097 8186

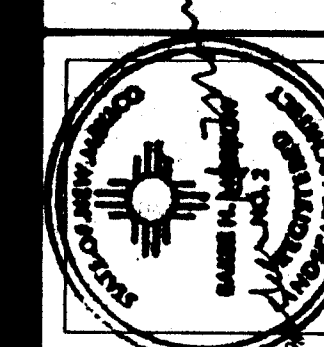



MORROW & COMPANY
LANDSCAPE ARCHITECTS
210 La Veta Drive NE
Albuquerque, New Mexico 87108
505-268-2266

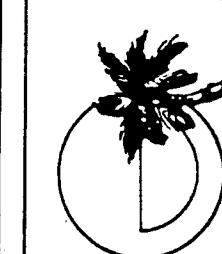NOVEMBER
1986


PONDEROSA WELL #3
9301 SPAIN NE

LANDSCAPING IMPROVEMENTS FOR
WATER SYSTEM FACILITY SITES
WATER SYSTEMS DIVISION
CITY OF ALBUQUERQUE
ALBUQUERQUE, NEW MEXICO

SHEET
98
OF
172

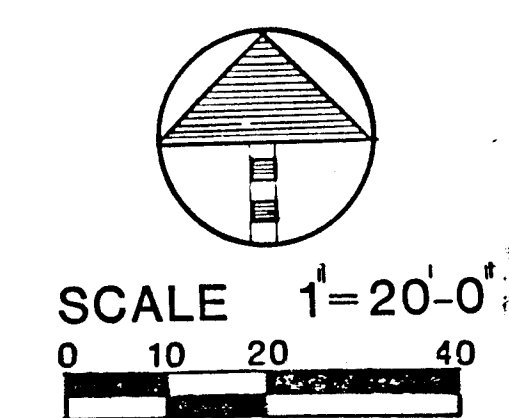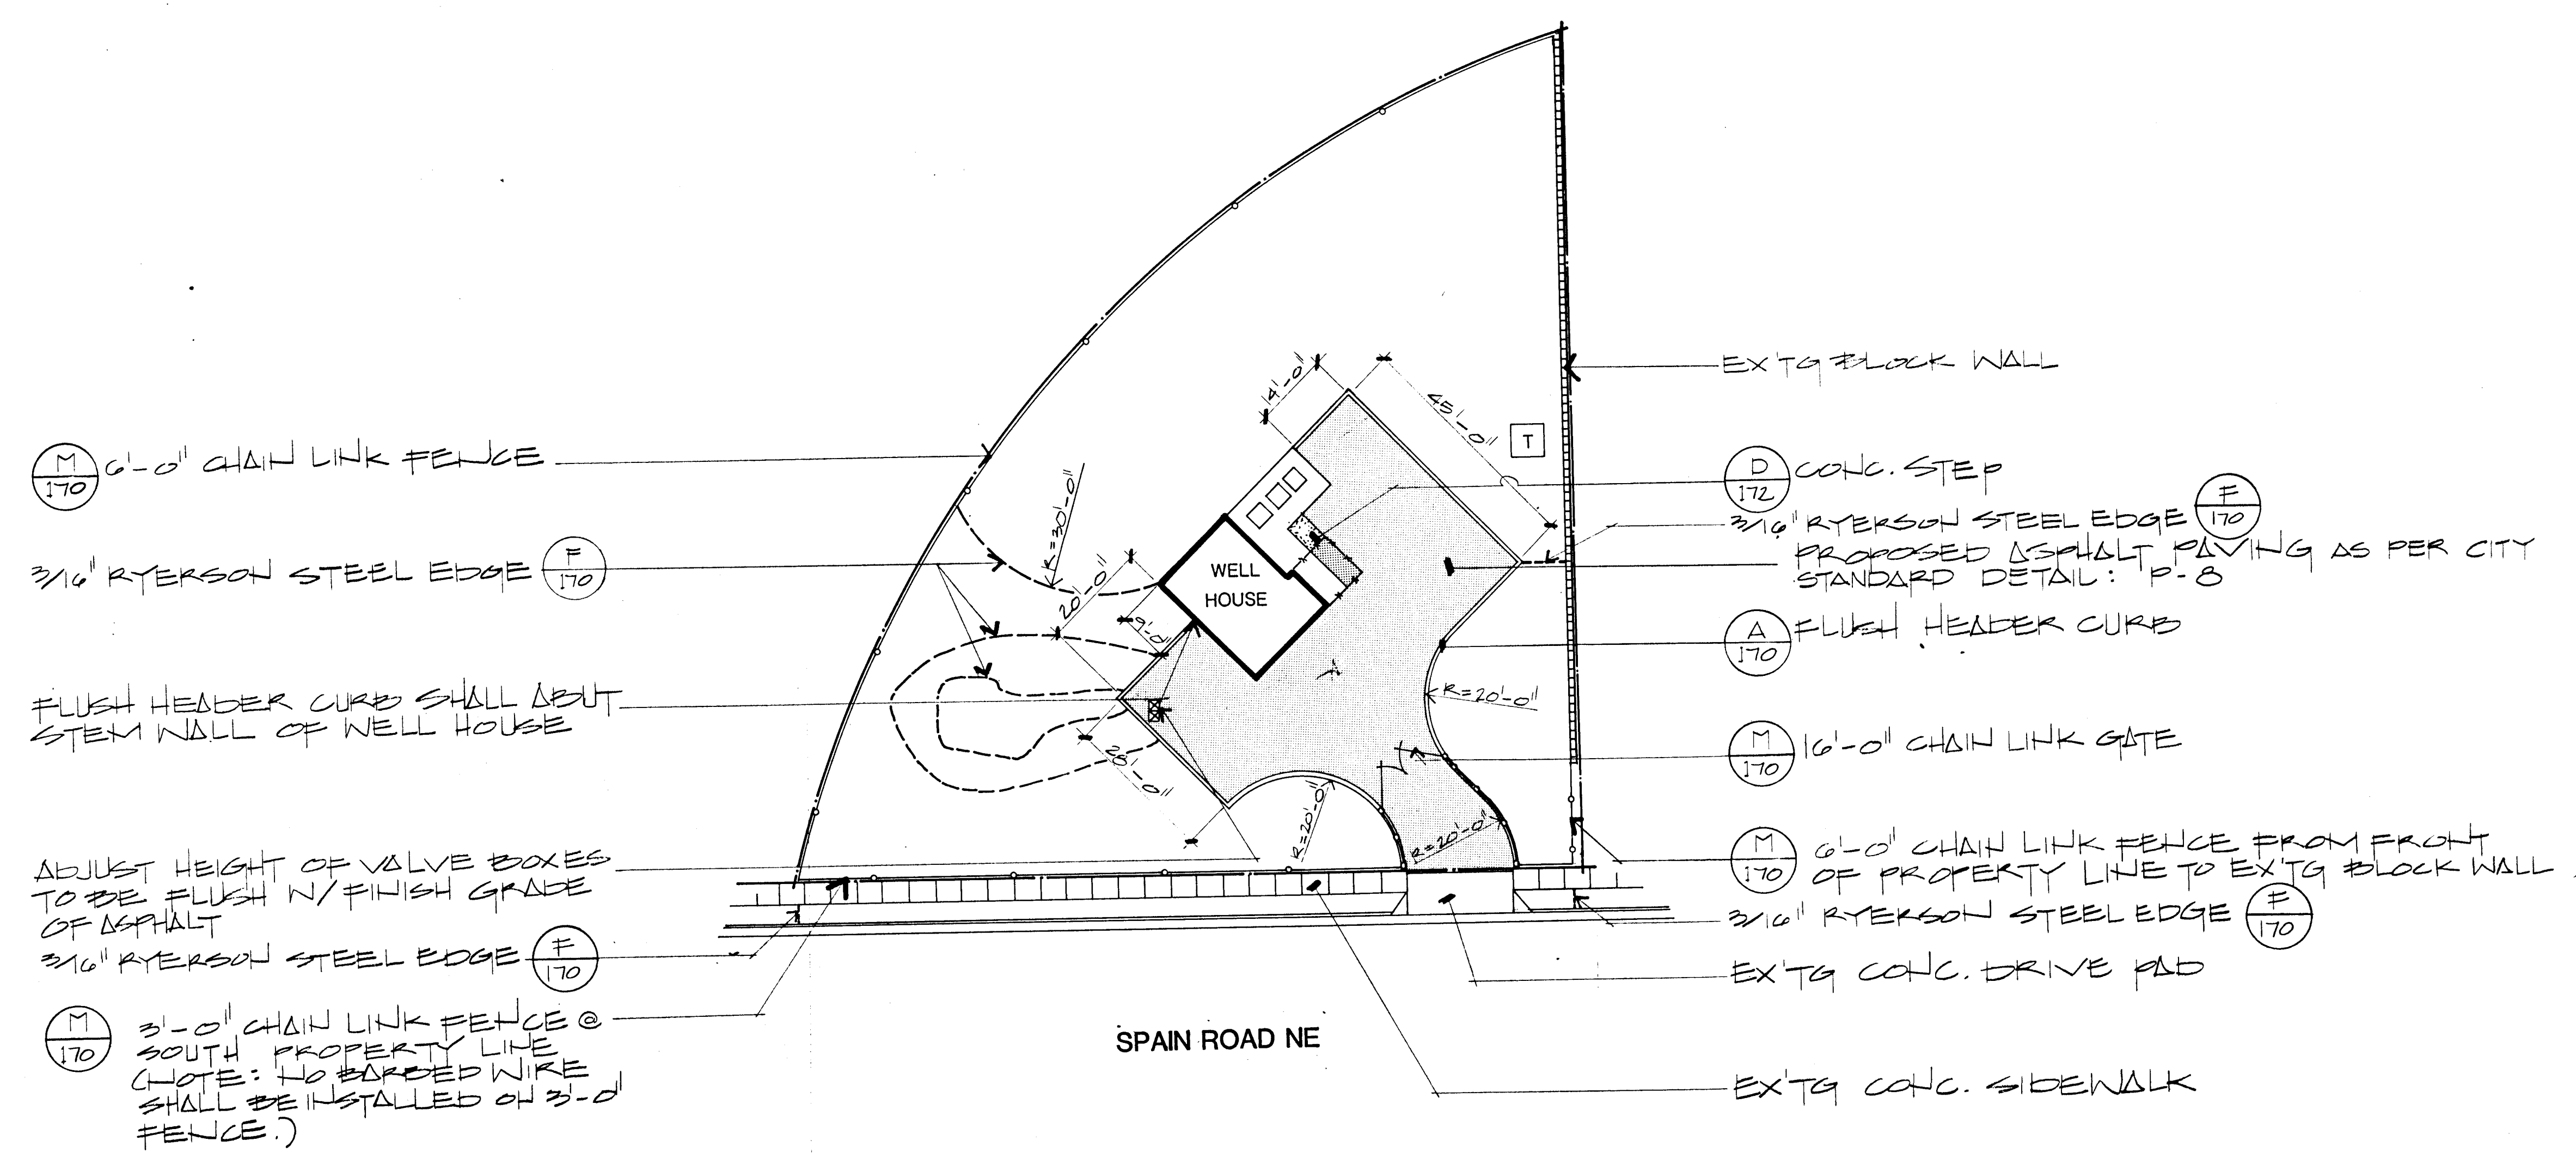

26 3097 8286

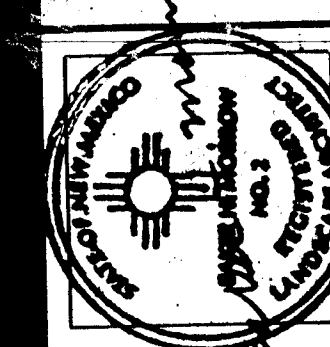

MORROW & COMPANY
LANDSCAPE ARCHITECTS
210 La Veta Drive NE
Atlanta, Georgia 30308
505-268-2266



NOVEMBER
1986

AS BUILT

PONDEROSA WELL #3
9301 SPAIN NE
CONSTRUCTION PLAN

LANDSCAPING IMPROVEMENTS FOR
WATER SYSTEM FACILITY SITES
WATER SYSTEMS DIVISION
CITY OF ALBUQUERQUE
ALBUQUERQUE, NEW MEXICO


SHEET
172

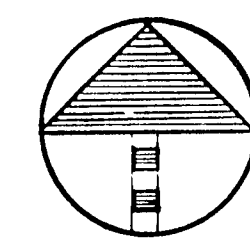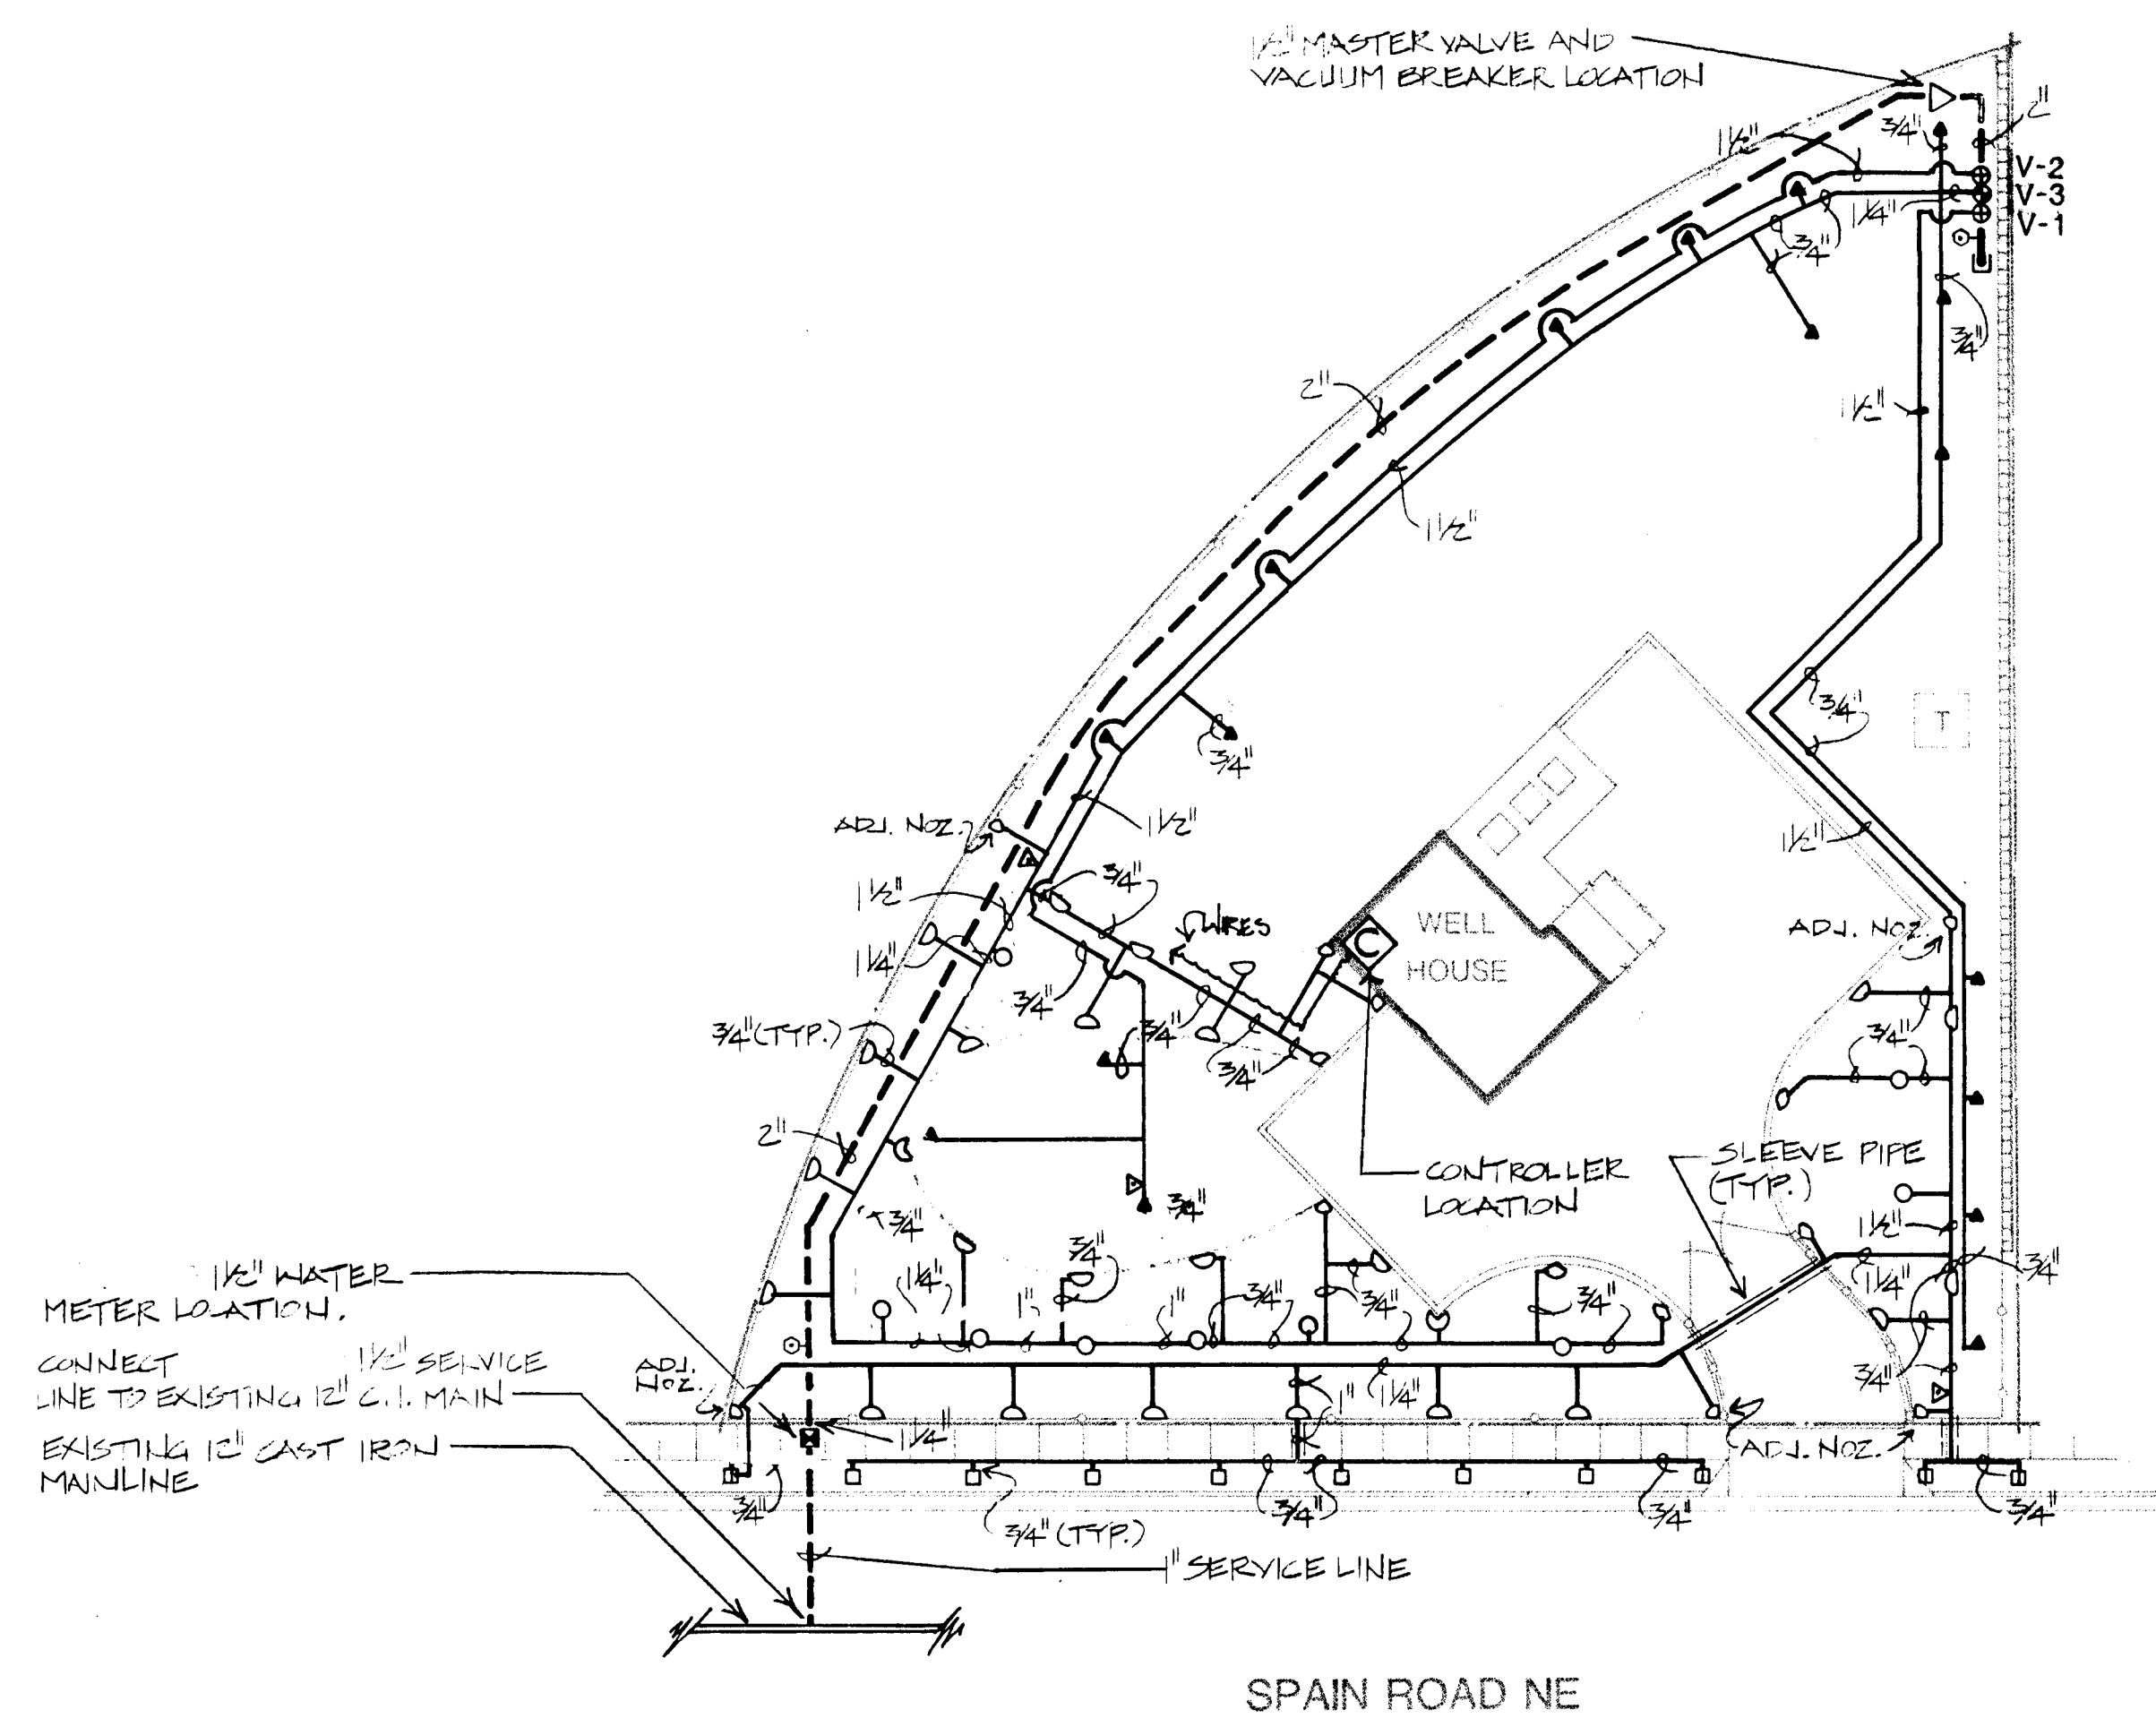


SCALE 1"=20'-0"

0 10 20 40

26 3097 838C

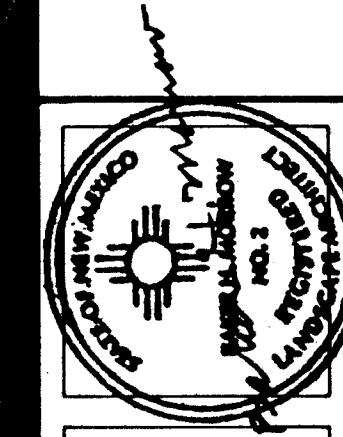

MORROW & COMPANY
LANDSCAPE ARCHITECTS
210 La Vista Drive NE
Albuquerque, New Mexico 87108
505-268-2266


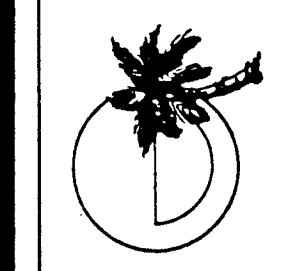


NOVEMBER
1996

PONDEROSA WELL #3
9301 SPAIN NE
IRRIGATION PLAN


LANDSCAPING IMPROVEMENTS FOR
WATER SYSTEM FACILITY SITES
WATER SYSTEMS DIVISION
CITY OF ALBUQUERQUE
ALBUQUERQUE, NEW MEXICO

SHEET
000
172

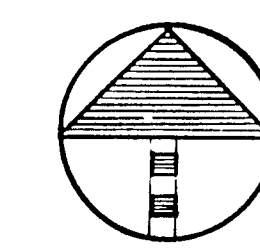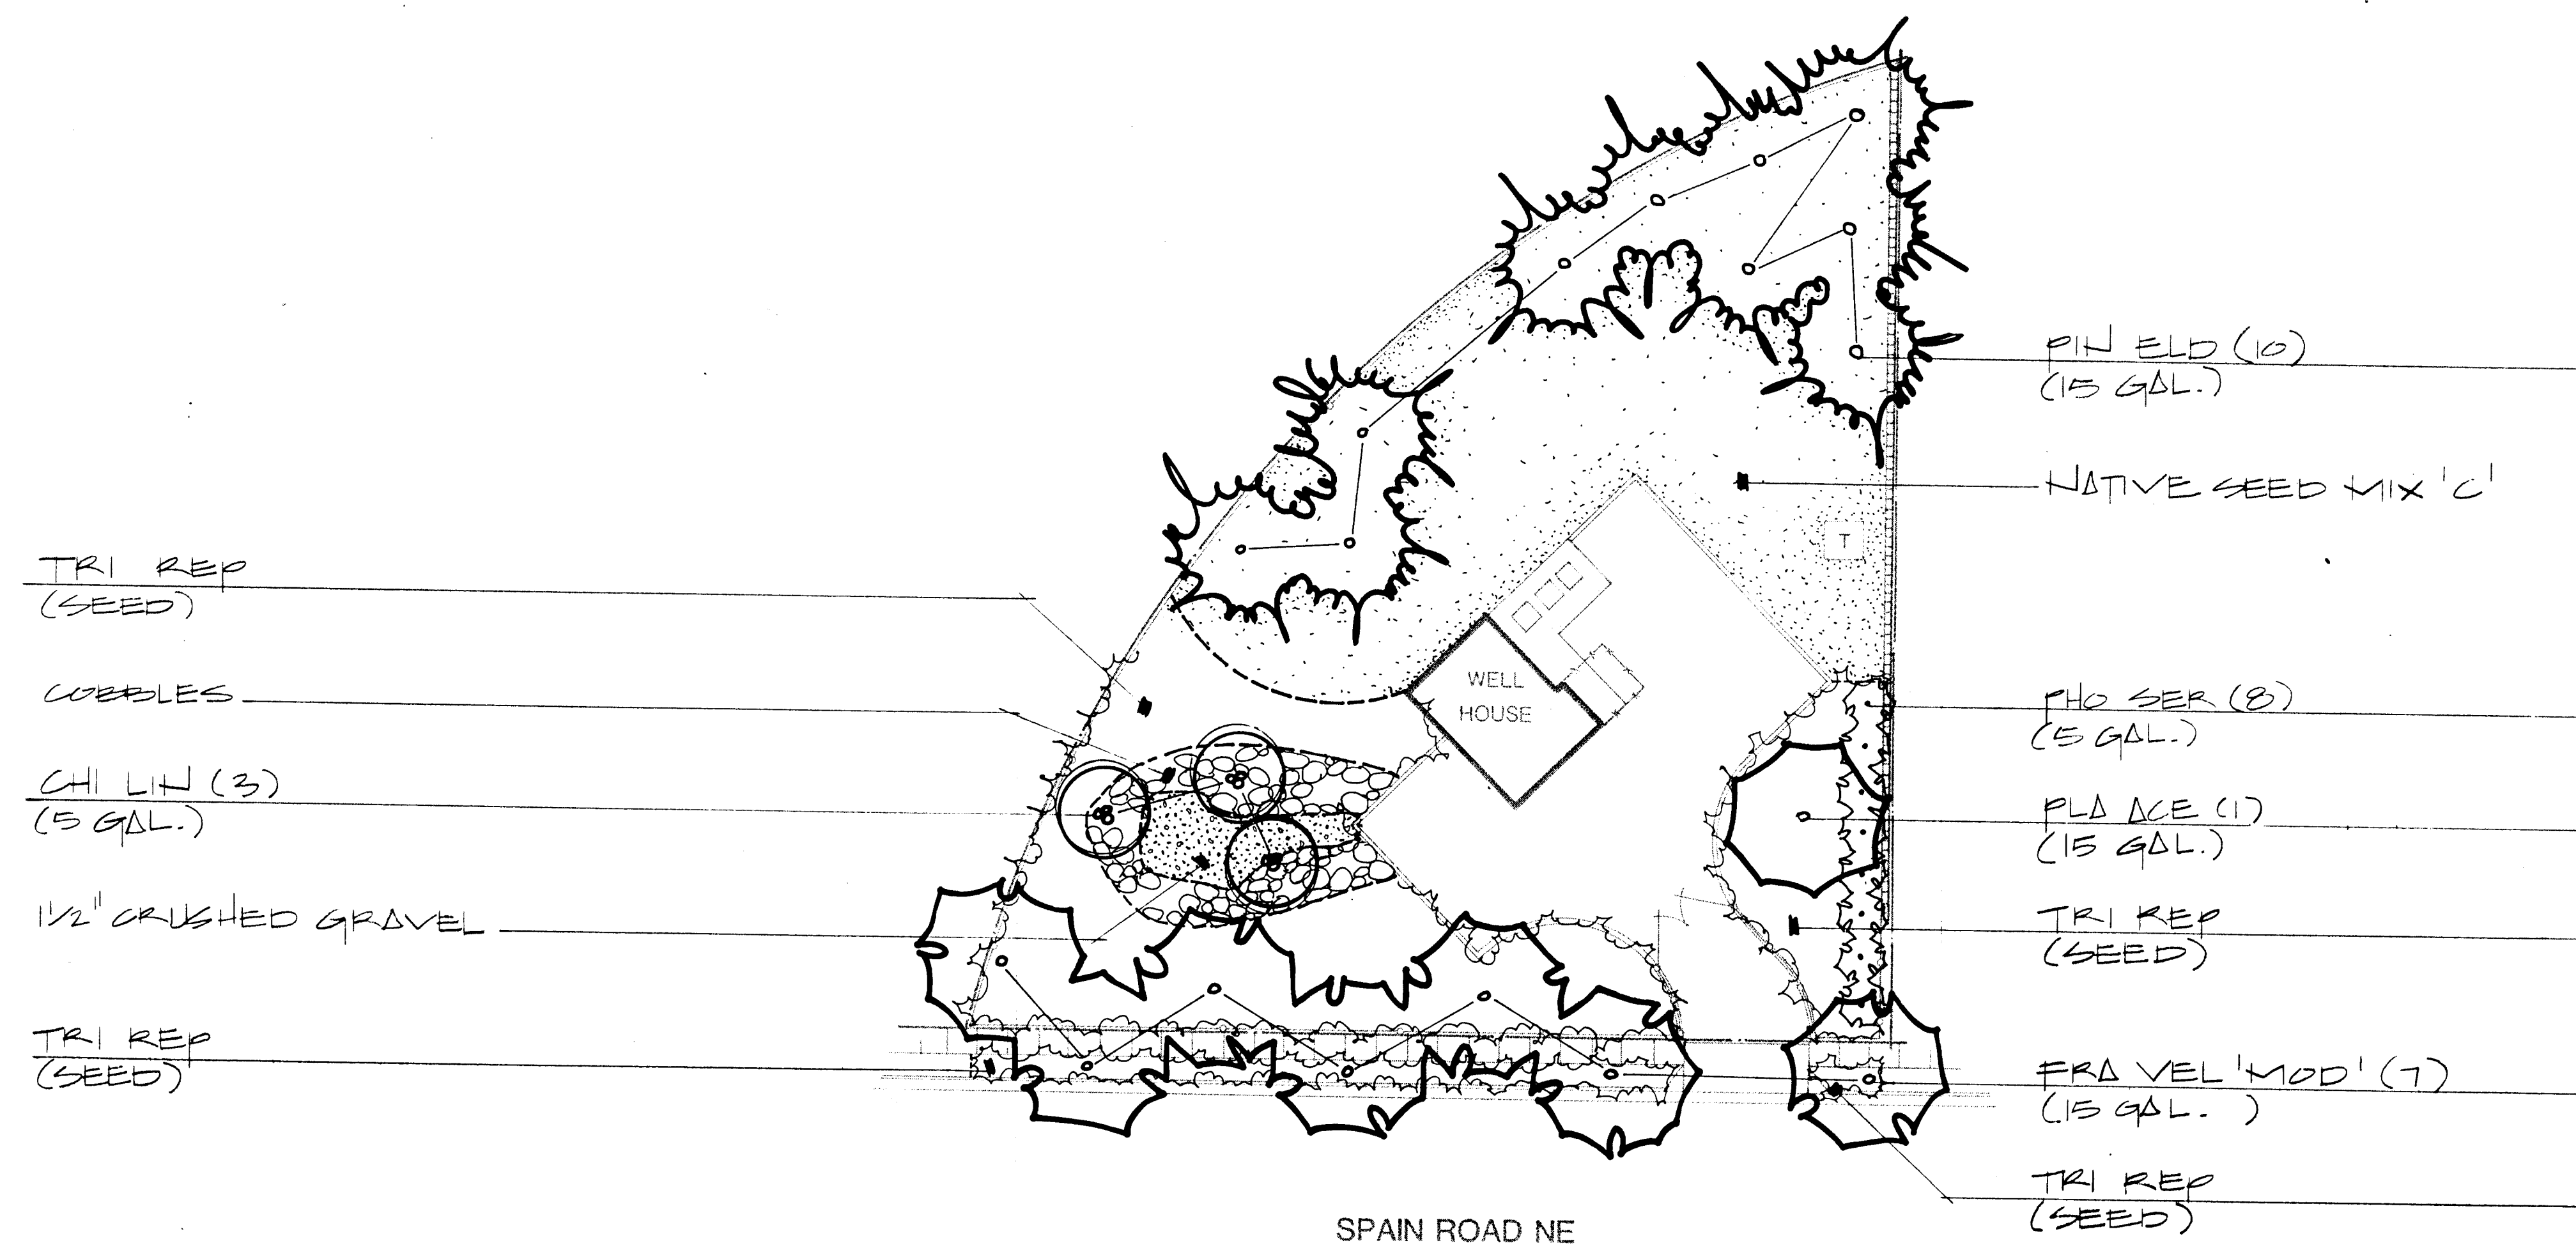


SCALE 1"=20'-0"

26 3097 8486

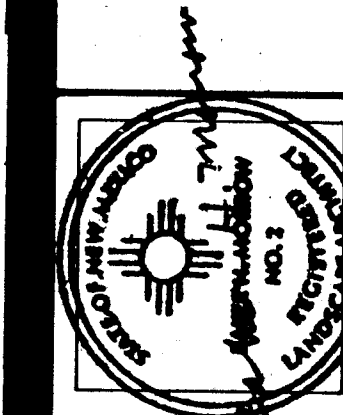

MORROW & COMPANY
LANDSCAPE ARCHITECTS
210 La Veta Drive NE
Albuquerque, New Mexico 87108
505-268-2266

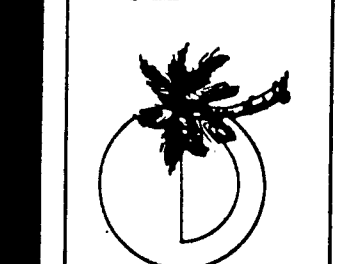

NOVEMBER
1986


AS BUILT

PONDEROSA WELL #3
9301 SPAIN NE
PLANTING PLAN


LANDSCAPING IMPROVEMENTS FOR
WATER SYSTEM FACILITY SITES
WATER RESOURCES DIVISION
CITY OF ALBUQUERQUE
ALBUQUERQUE, NEW MEXICO

SHEET
13
172


NOTE:
Street and sidewalk construction (by others - NIC) may be on-going during the construction of the landscape improvements described herein. The Contractor shall coordinate all proposed landscape construction with the on-going construction of the street and sidewalk. The Contractor shall notify the Landscape Architect of any problems that may occur concerning the coordination of the two projects.

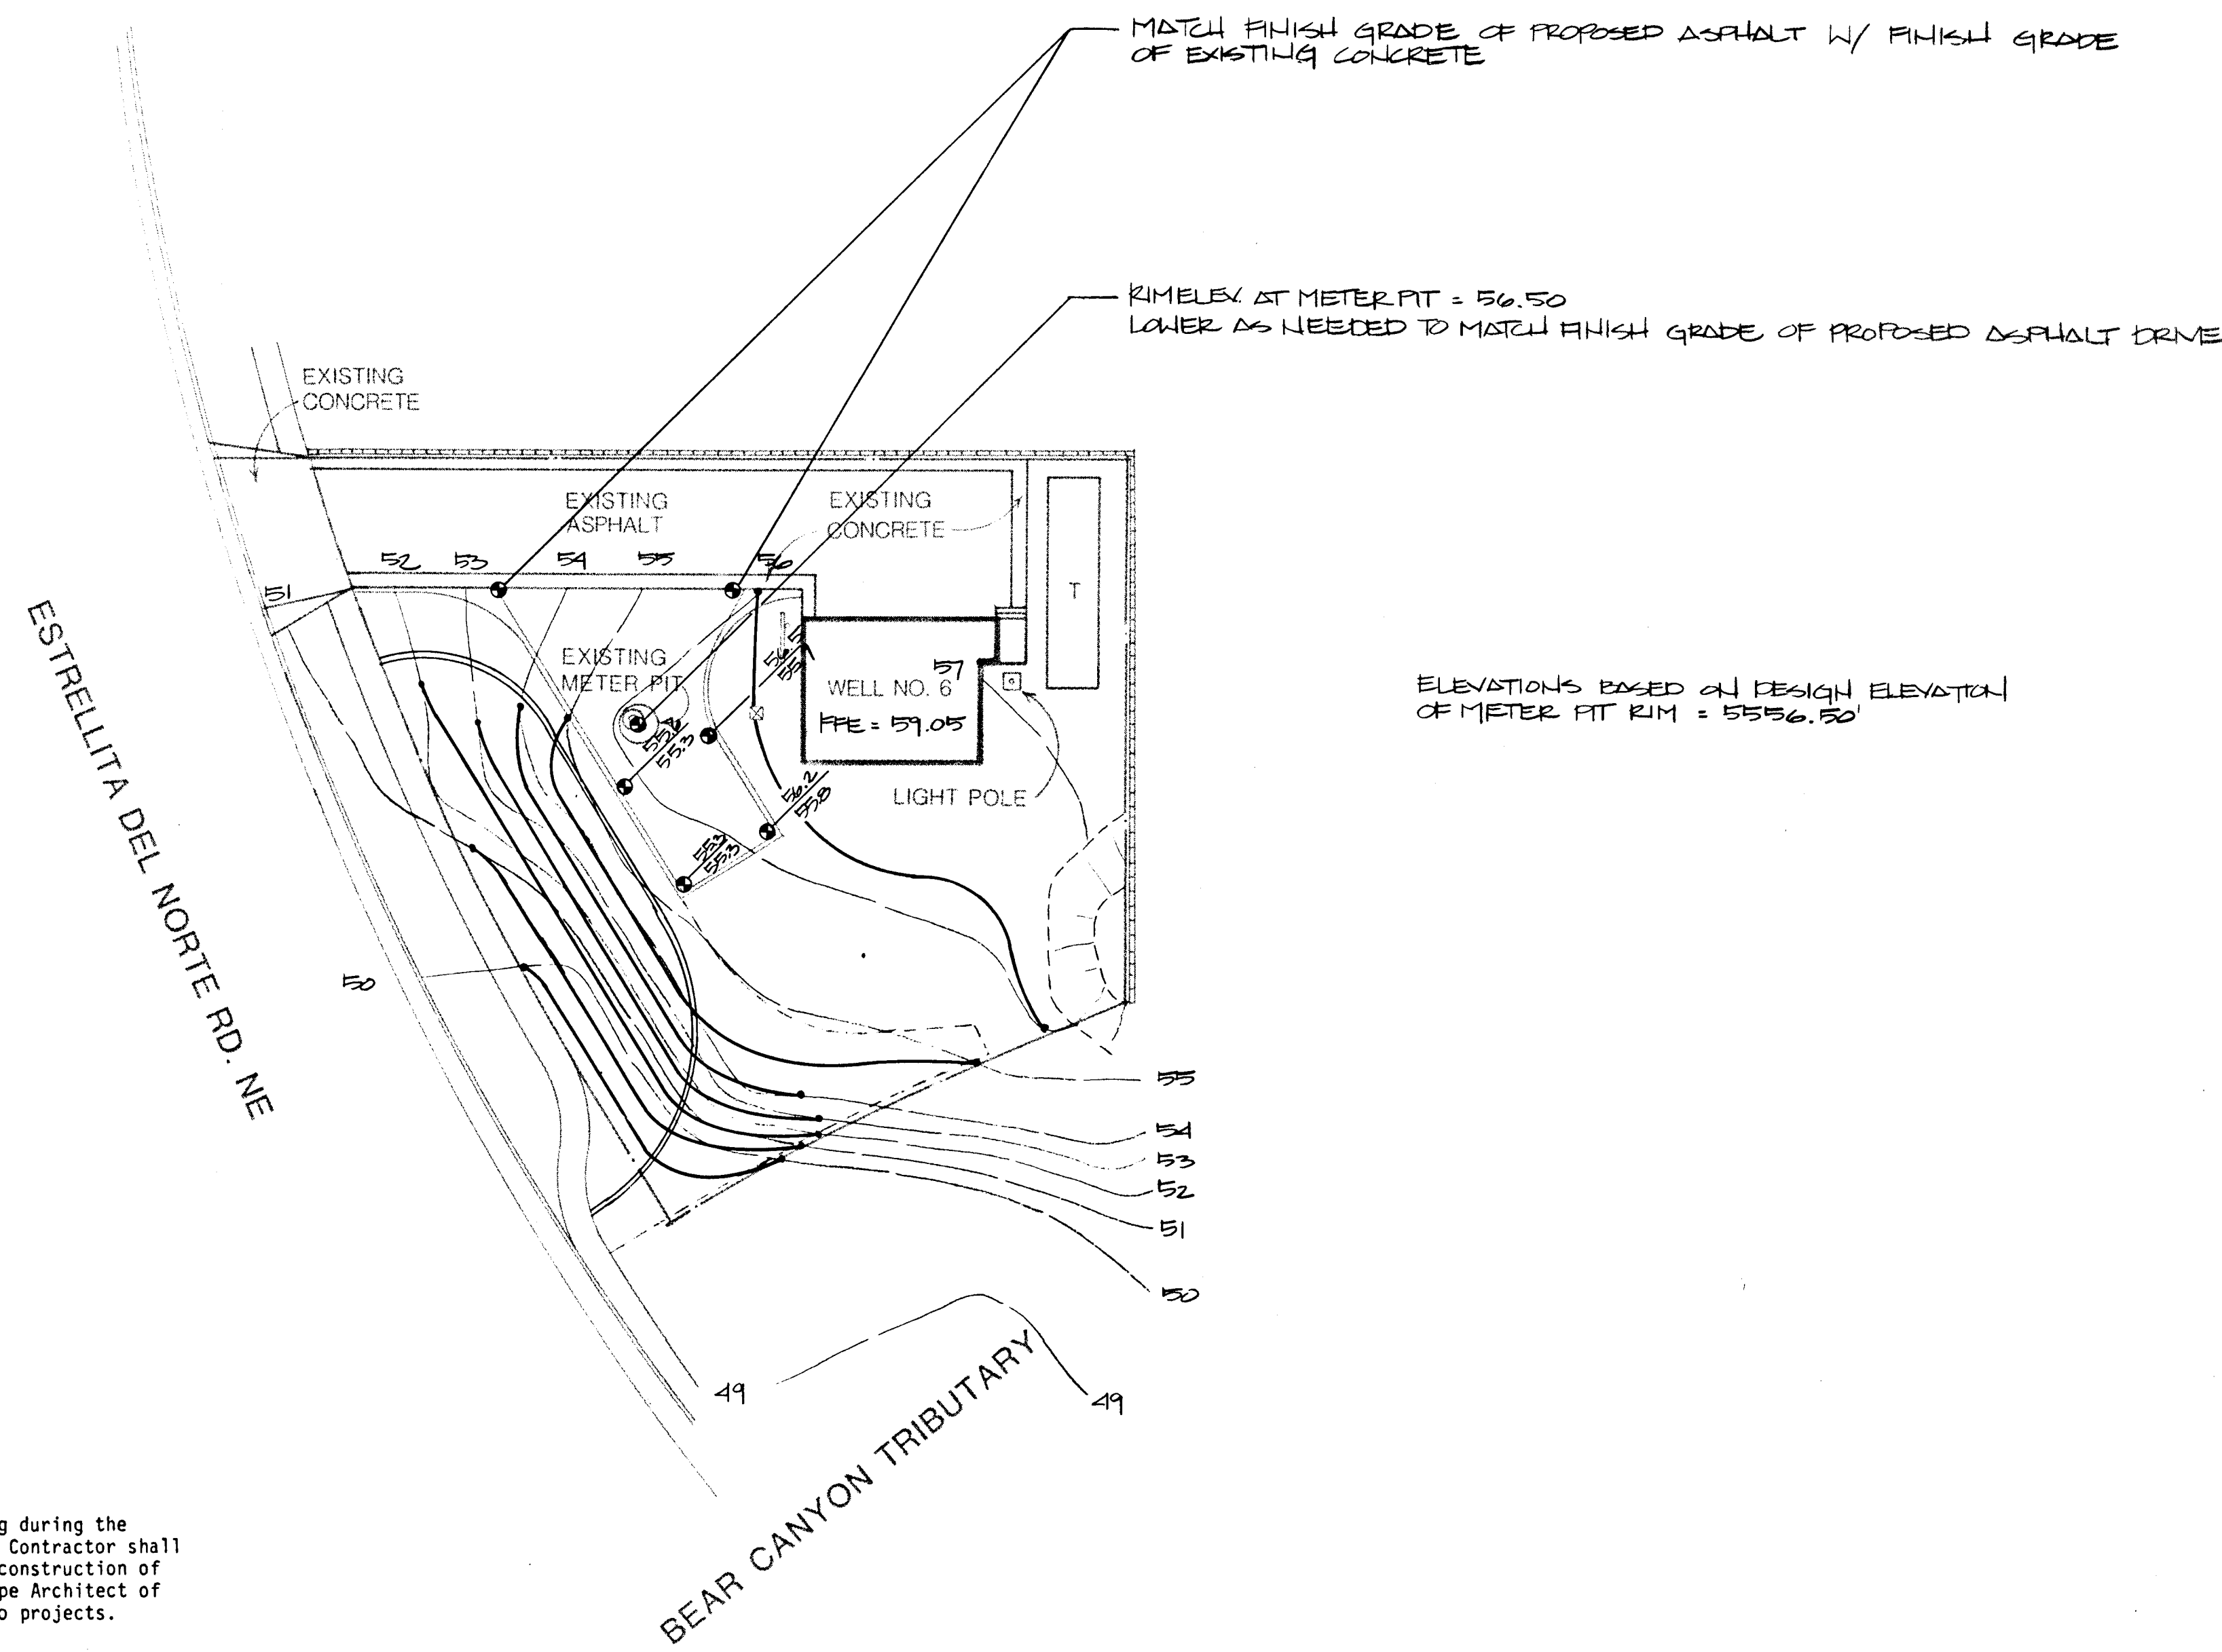

SCALE 1"=20'-0"

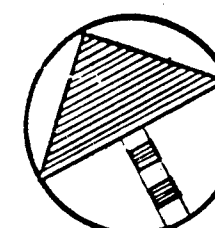

26 3097 8586

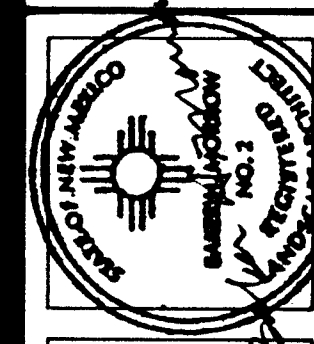

MORROW & COMPANY
LANDSCAPE ARCHITECTS
210 La Veta Drive NE
Albuquerque, New Mexico 87108
505-268-2268




NOVEMBER
1986

AS BUILT

PONDEROSA WELL #6
5900 ESTRELLITA DEL NORTE NE
GRADING PLAN

LANDSCAPING IMPROVEMENTS FOR
WATER SYSTEM FACILITY SITES
WATER RESOURCES DIVISION
CITY OF ALBUQUERQUE, NEW MEXICO

SHEET
102
172


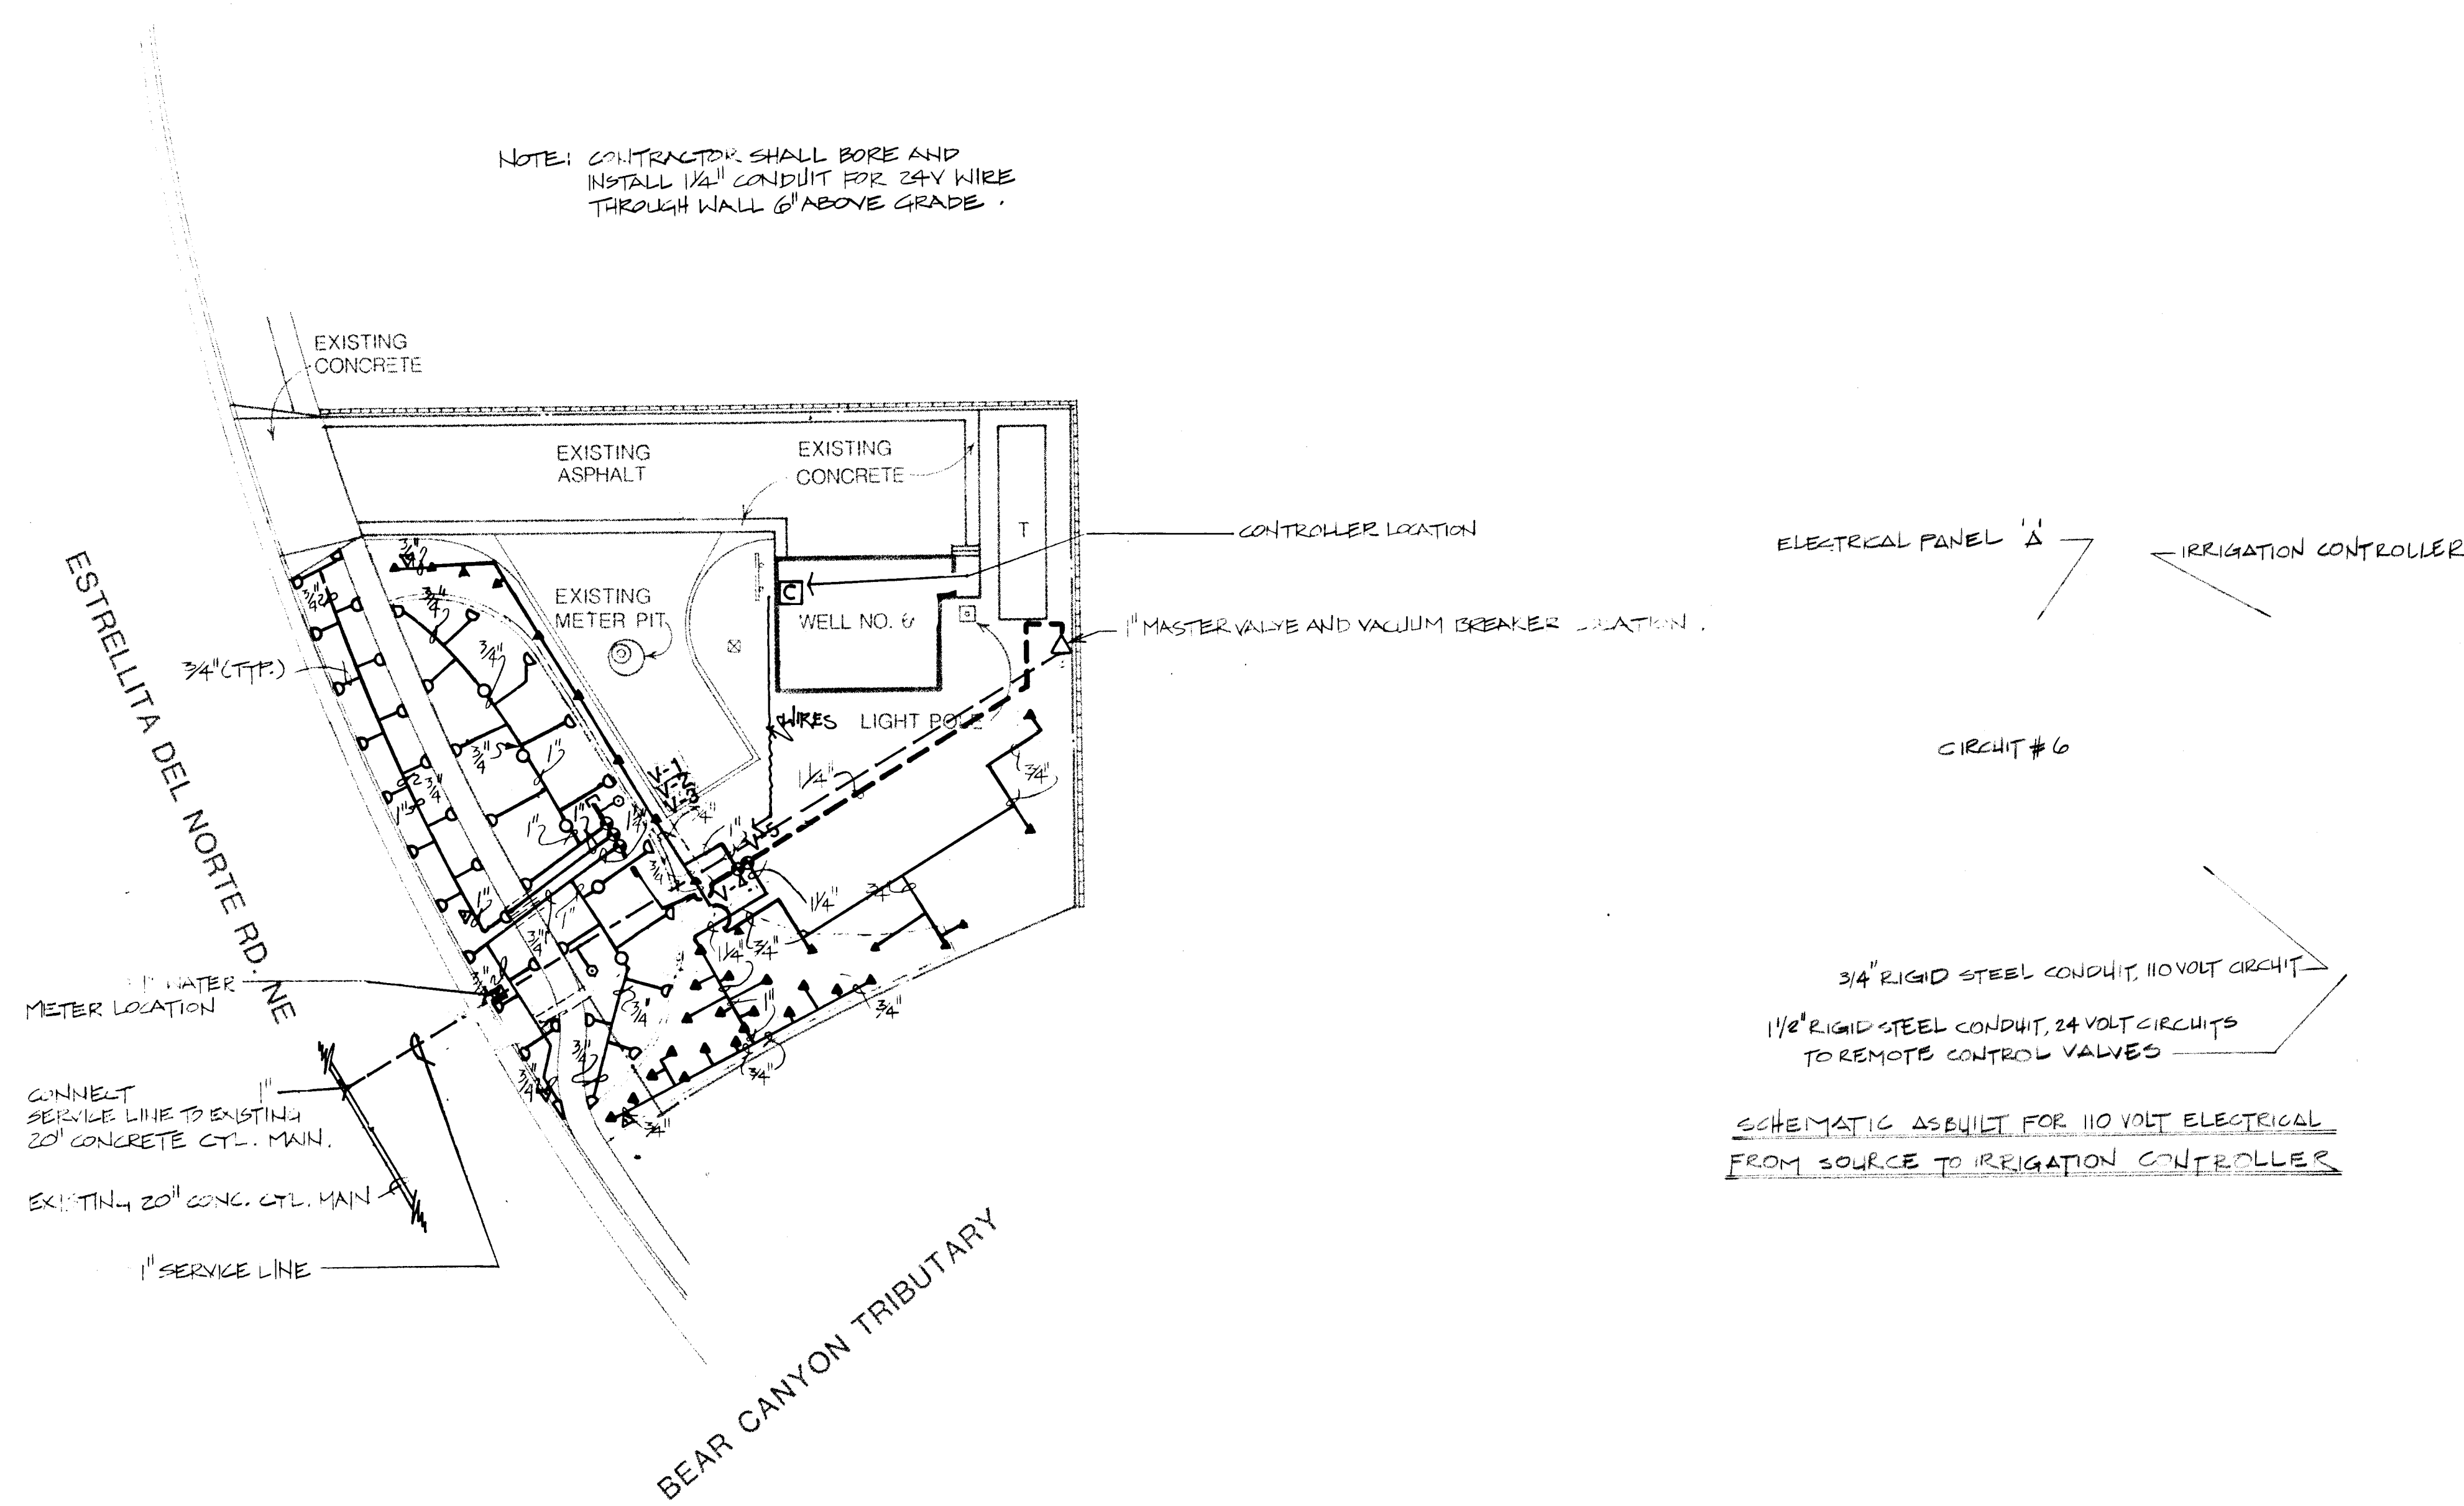


NOTE:
Street and sidewalk construction (by others - NIC) may be on-going during the construction of the landscape improvements described herein. The Contractor shall coordinate all proposed landscape construction with the on-going construction of the street and sidewalk. The Contractor shall notify the Landscape Architect of any problems that may occur concerning the coordination of the two projects.

SCALE 1"=20'-0"

0 10 20 40

26 3097 8786

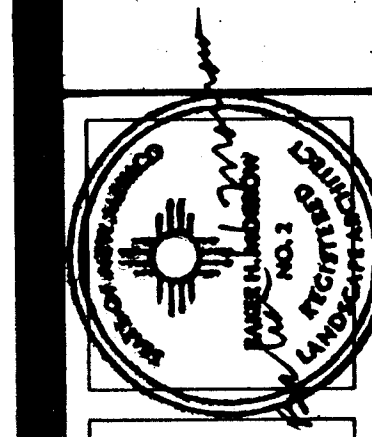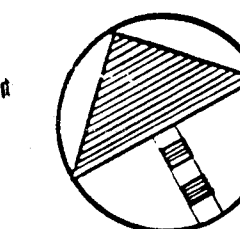

MORROW & COMPANY
LANDSCAPE ARCHITECTS
200 LA VISTA DRIVE, NE
ALBUQUERQUE, NEW MEXICO 87108
505-268-2266


NOVEMBER
1986

AS BUILT

PONDEROSA WELL #6
5900 ESTRELLITA DEL NORTE NE
IRRIGATION PLAN


LANDSCAPING IMPROVEMENTS FOR
WATER SYSTEM FACILITY SITES
CITY OF ALBUQUERQUE, NEW MEXICO

SHEET
1054
72

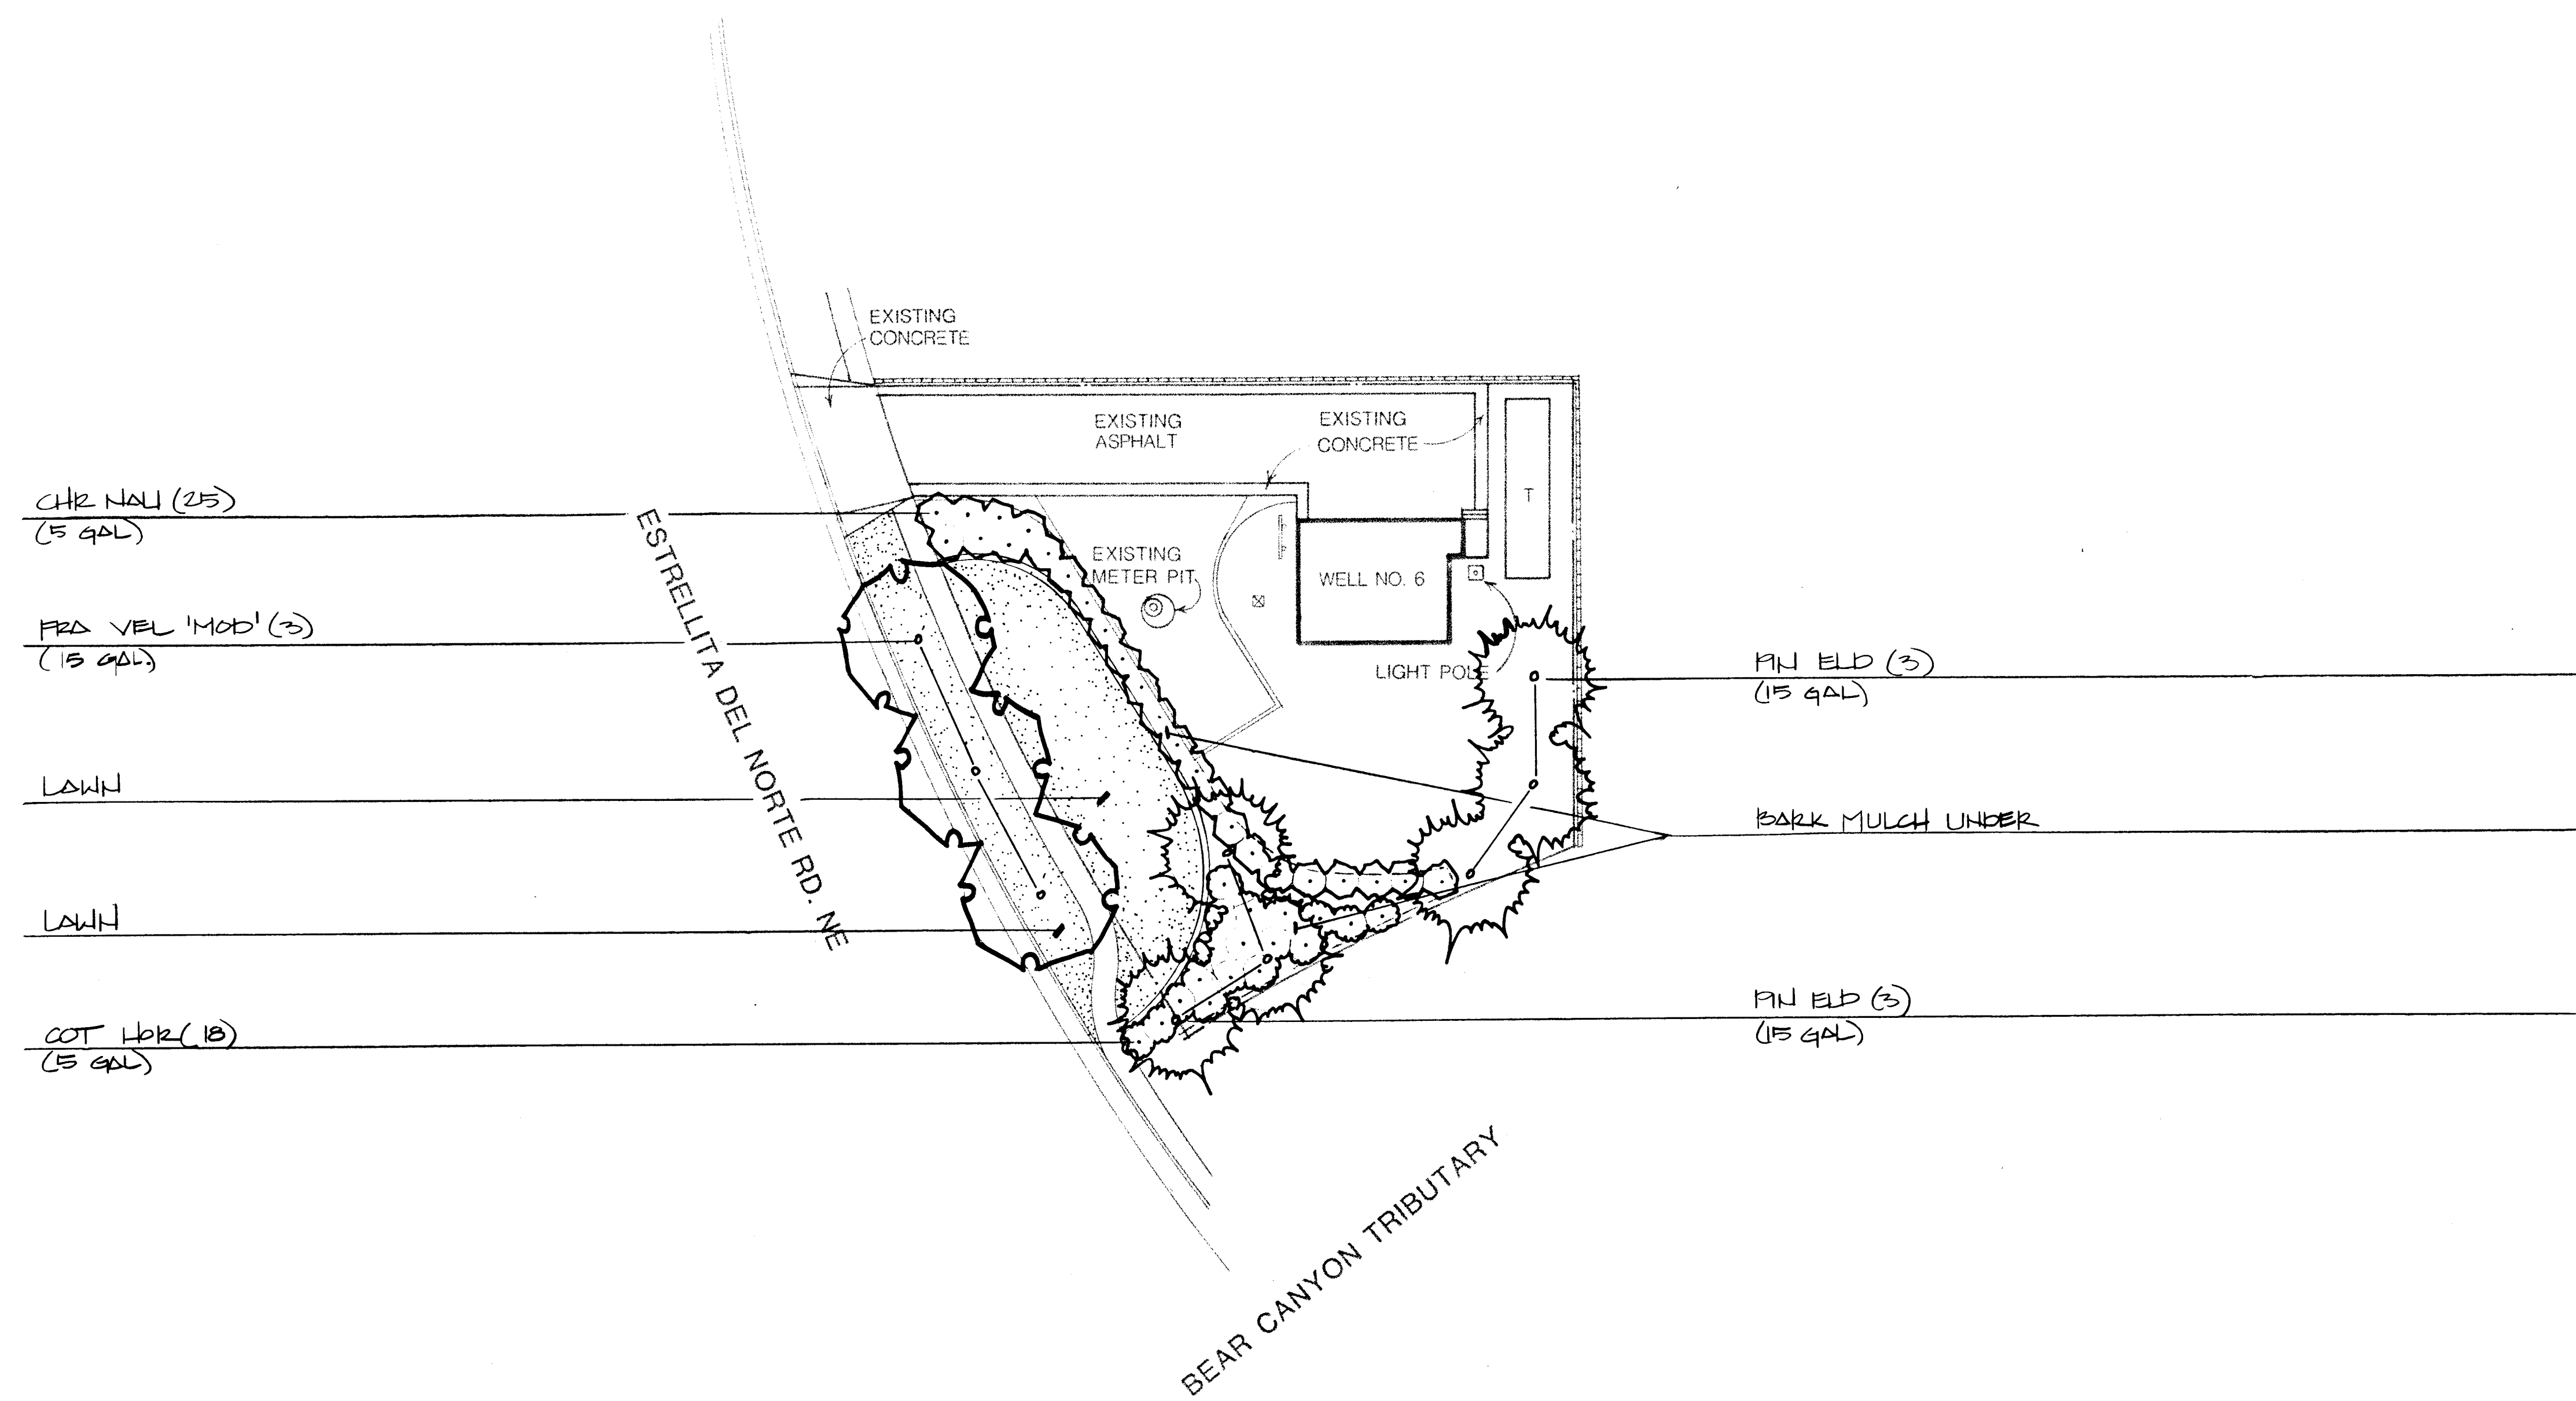


NOTE:
Street and sidewalk construction (by others - NIC) may be on-going during the construction of the landscape improvements described herein. The Contractor shall coordinate all proposed landscape construction with the on-going construction of the street and sidewalk. The Contractor shall notify the Landscape Architect of any problems that may occur concerning the coordination of the two projects.


SCALE 1"=20'-0"
0 10 20 40

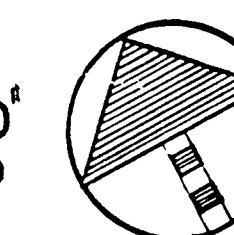

26 3097 8086

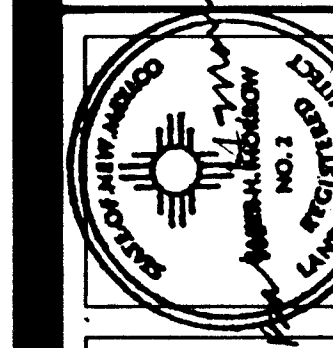

MORROW & COMPANY
LANDSCAPE ARCHITECTS
210 La Veta Drive NE
Albuquerque, New Mexico 87108
505-268-2266

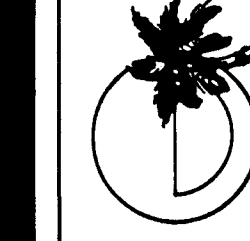

NOVEMBER
1986


AS BUILT

PONDEROSA WELL #6
5900 ESTRELLITA DEL NORTE NE
PLANTING PLAN

LANDSCAPING IMPROVEMENTS FOR
WATER SYSTEM FACILITY SITES
WATER SYSTEMS DIVISION
CITY OF ALBUQUERQUE
ALBUQUERQUE, NEW MEXICO

SHEET


10
11
12

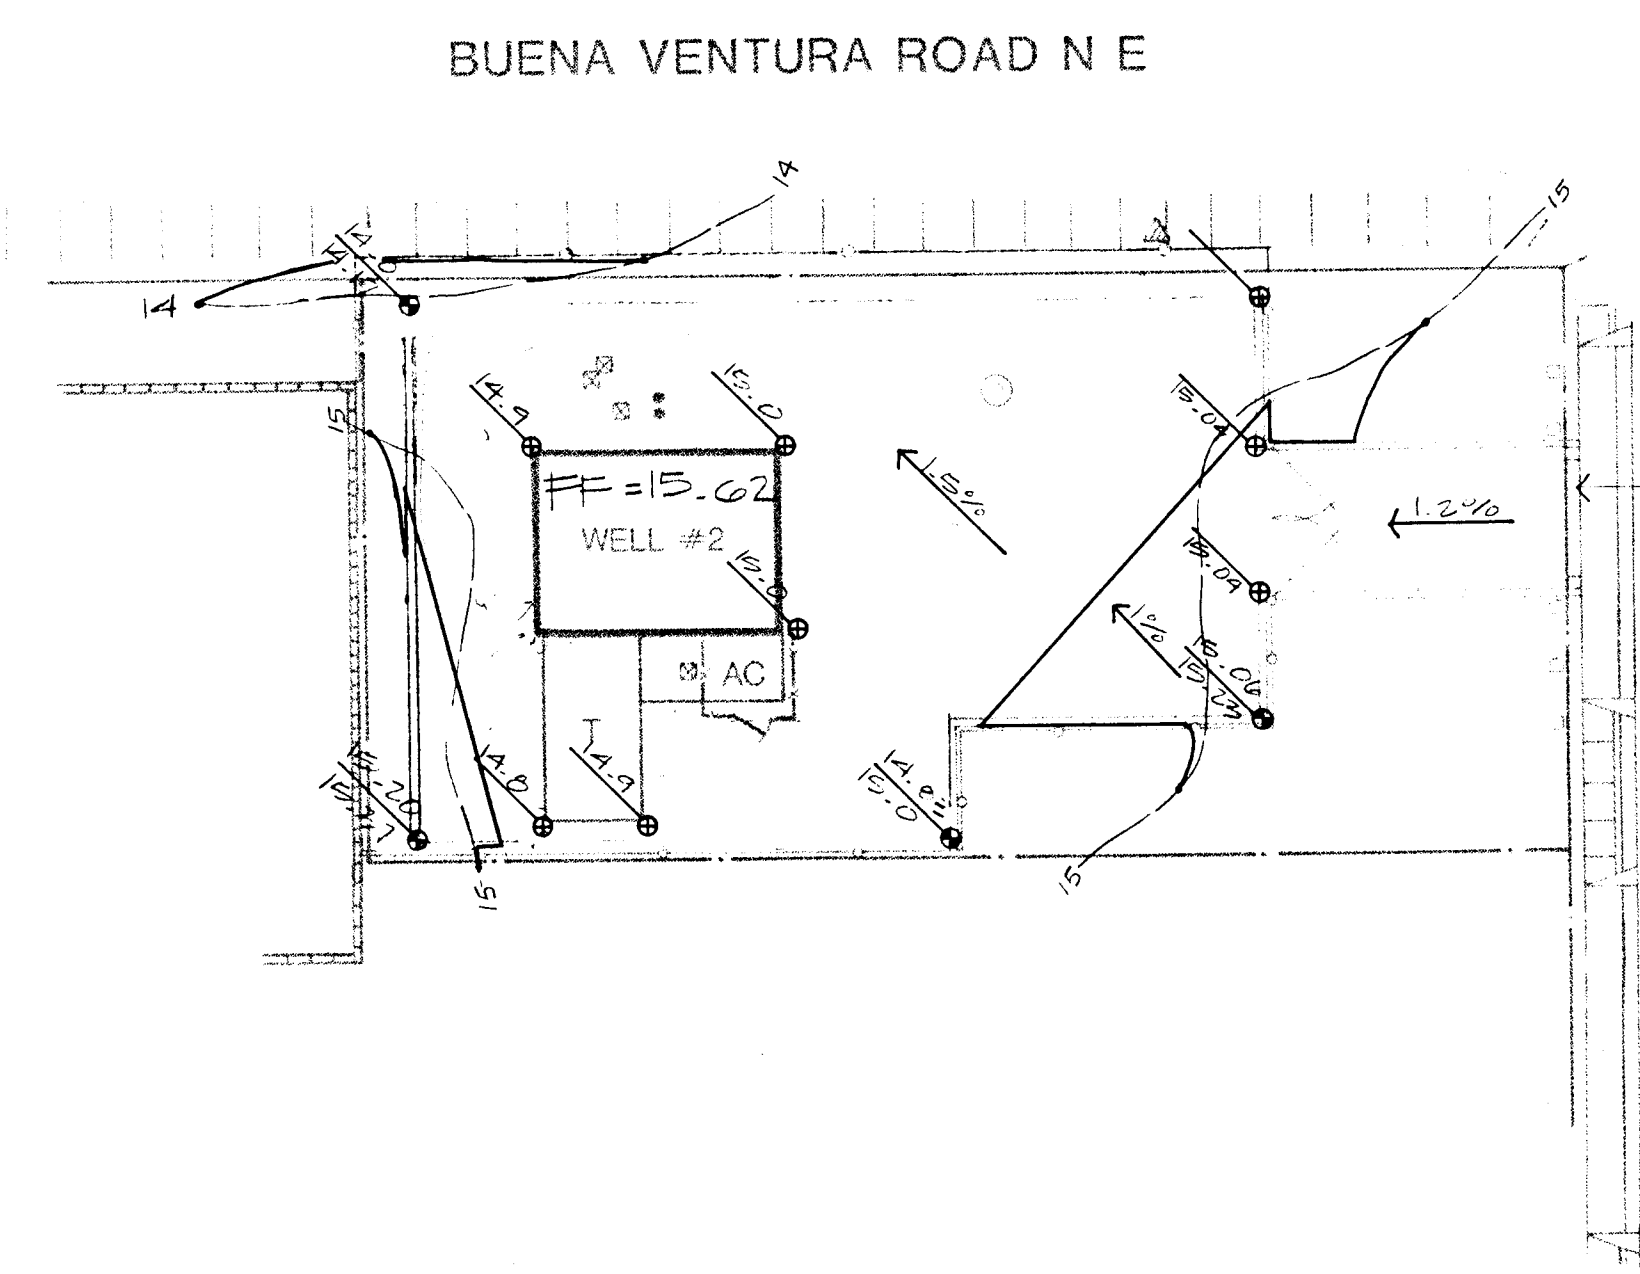


GENERAL PATCH N E

MATCH GRADE OF PROPOSED
ASPHALT TO EXISTING DRIVE PAD

SCALE 1"=20'-0"

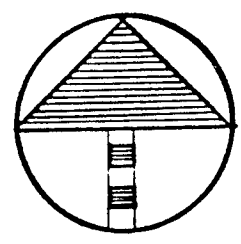

26 3097 8986

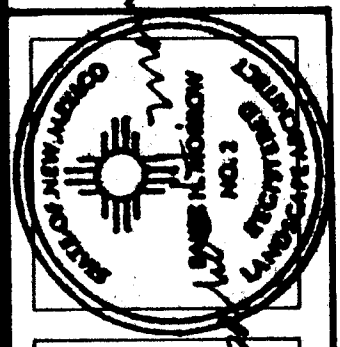

MORROW & COMPANY
LANDSCAPE ARCHITECTS
210 La Veta Drive NE
Albuquerque, New Mexico 87108
505.266.2266

NOVEMBER
1986

AS BUILT
RIDGECREST WELL #2
125 GENERAL PATCH
GRADING PLAN

LANDSCAPING IMPROVEMENTS FOR
WATER SYSTEM FACILITY SITES
WATER SYSTEM FACILITY SITES
CITY OF ALBUQUERQUE
ALBUQUERQUE, NEW MEXICO

SHEET
106
172


NOTE:
ADJUST VALVE BOXES &
MANHOLES TO BE FLUSH W/
FINISH GRADE (TYP. THROUGH-
OUT ASPHALT)

(A) FLUSH HEADER CURB


ASPHALT DRIVE AS PER CITY
STANDARD DETAIL P-8

ASPHALT SHALL BE INSTALLED FLUSH
W/EXTG CONC. PAD

(M) CHAINLINK FENCE

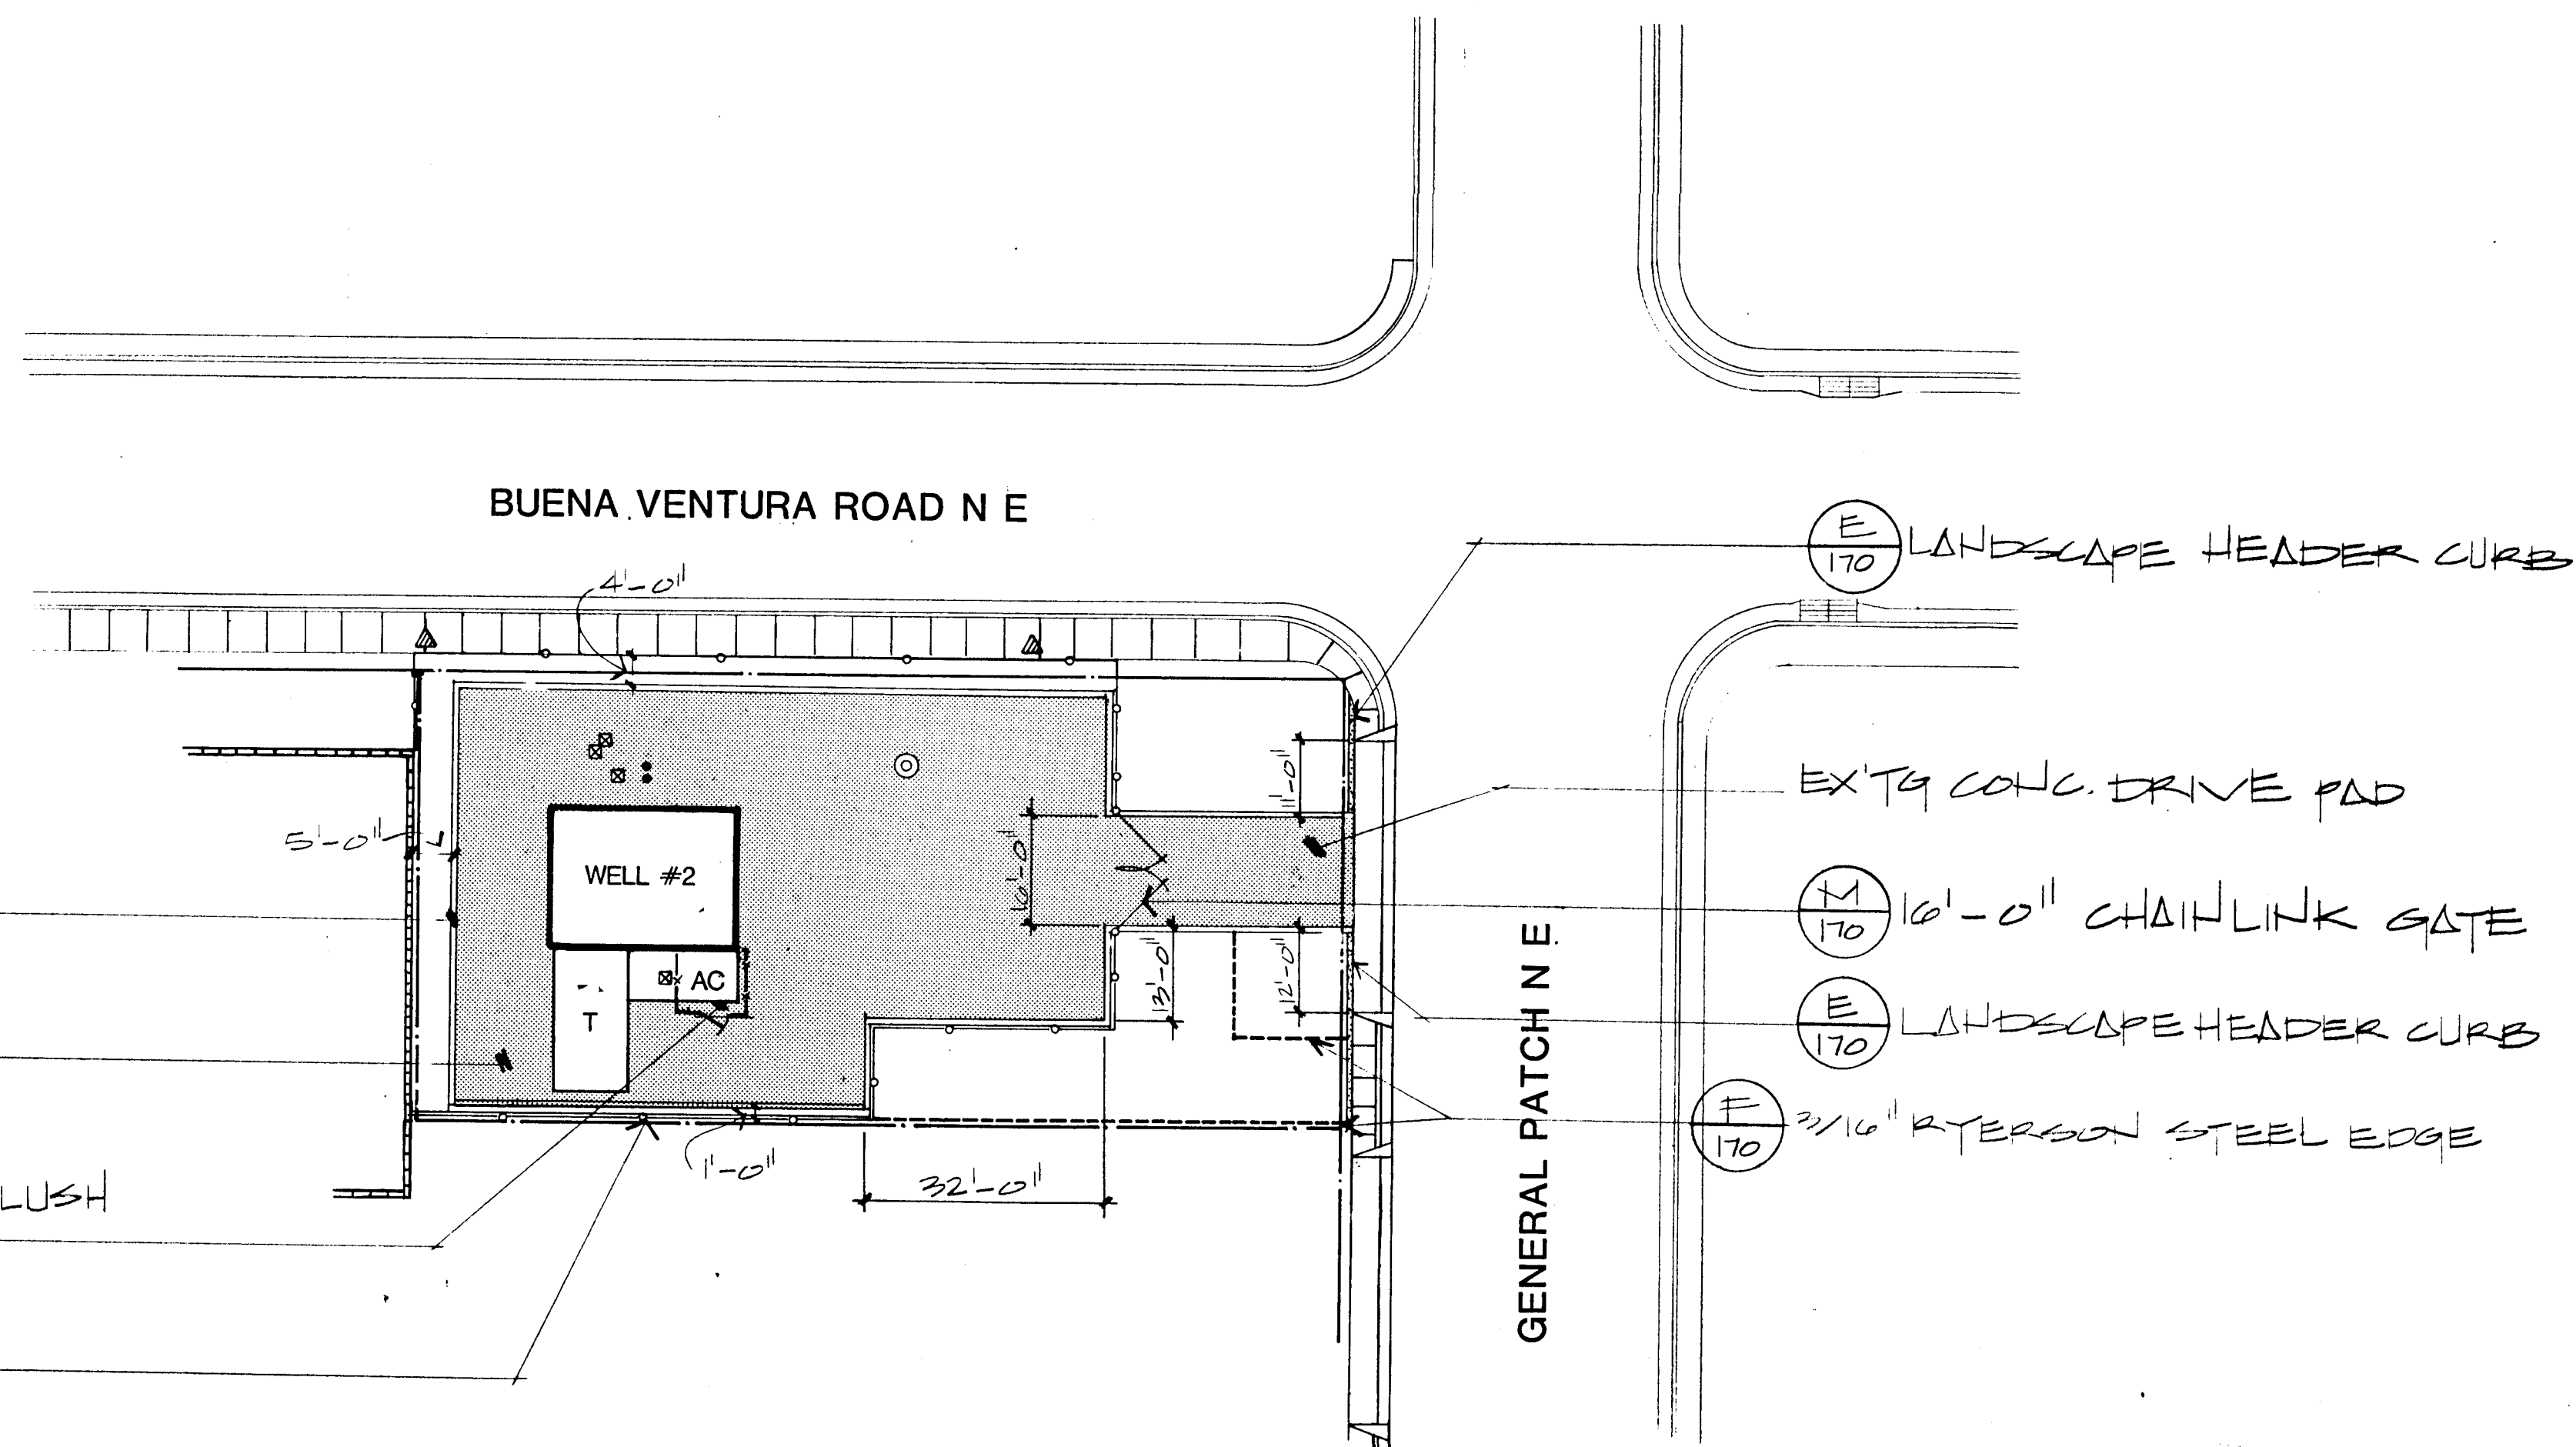

SCALE 1"=20'-0"
0 10 20 40

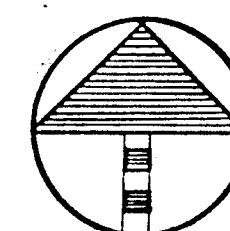

26 3097 9086



LANDSCAPING IMPROVEMENTS FOR
WATER SYSTEM FACILITY SITES
WATER SYSTEMS DIVISION
CITY OF ALBUQUERQUE
ALBUQUERQUE, NEW MEXICO

RIDGECREST WELL #2
125 GENERAL PATCH
CONSTRUCTION PLAN


AS BUILT

NOVEMBER
1986


MORROW & COMPANY
LANDSCAPE ARCHITECTS
210 La Veta Drive NE
Albuquerque, New Mexico 87108
505-268-2266

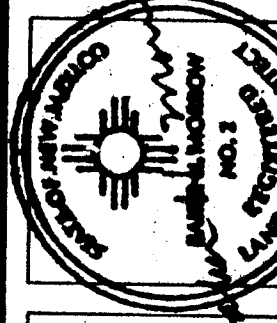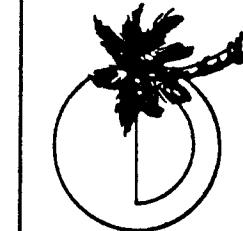

SHEET
19
OF
172

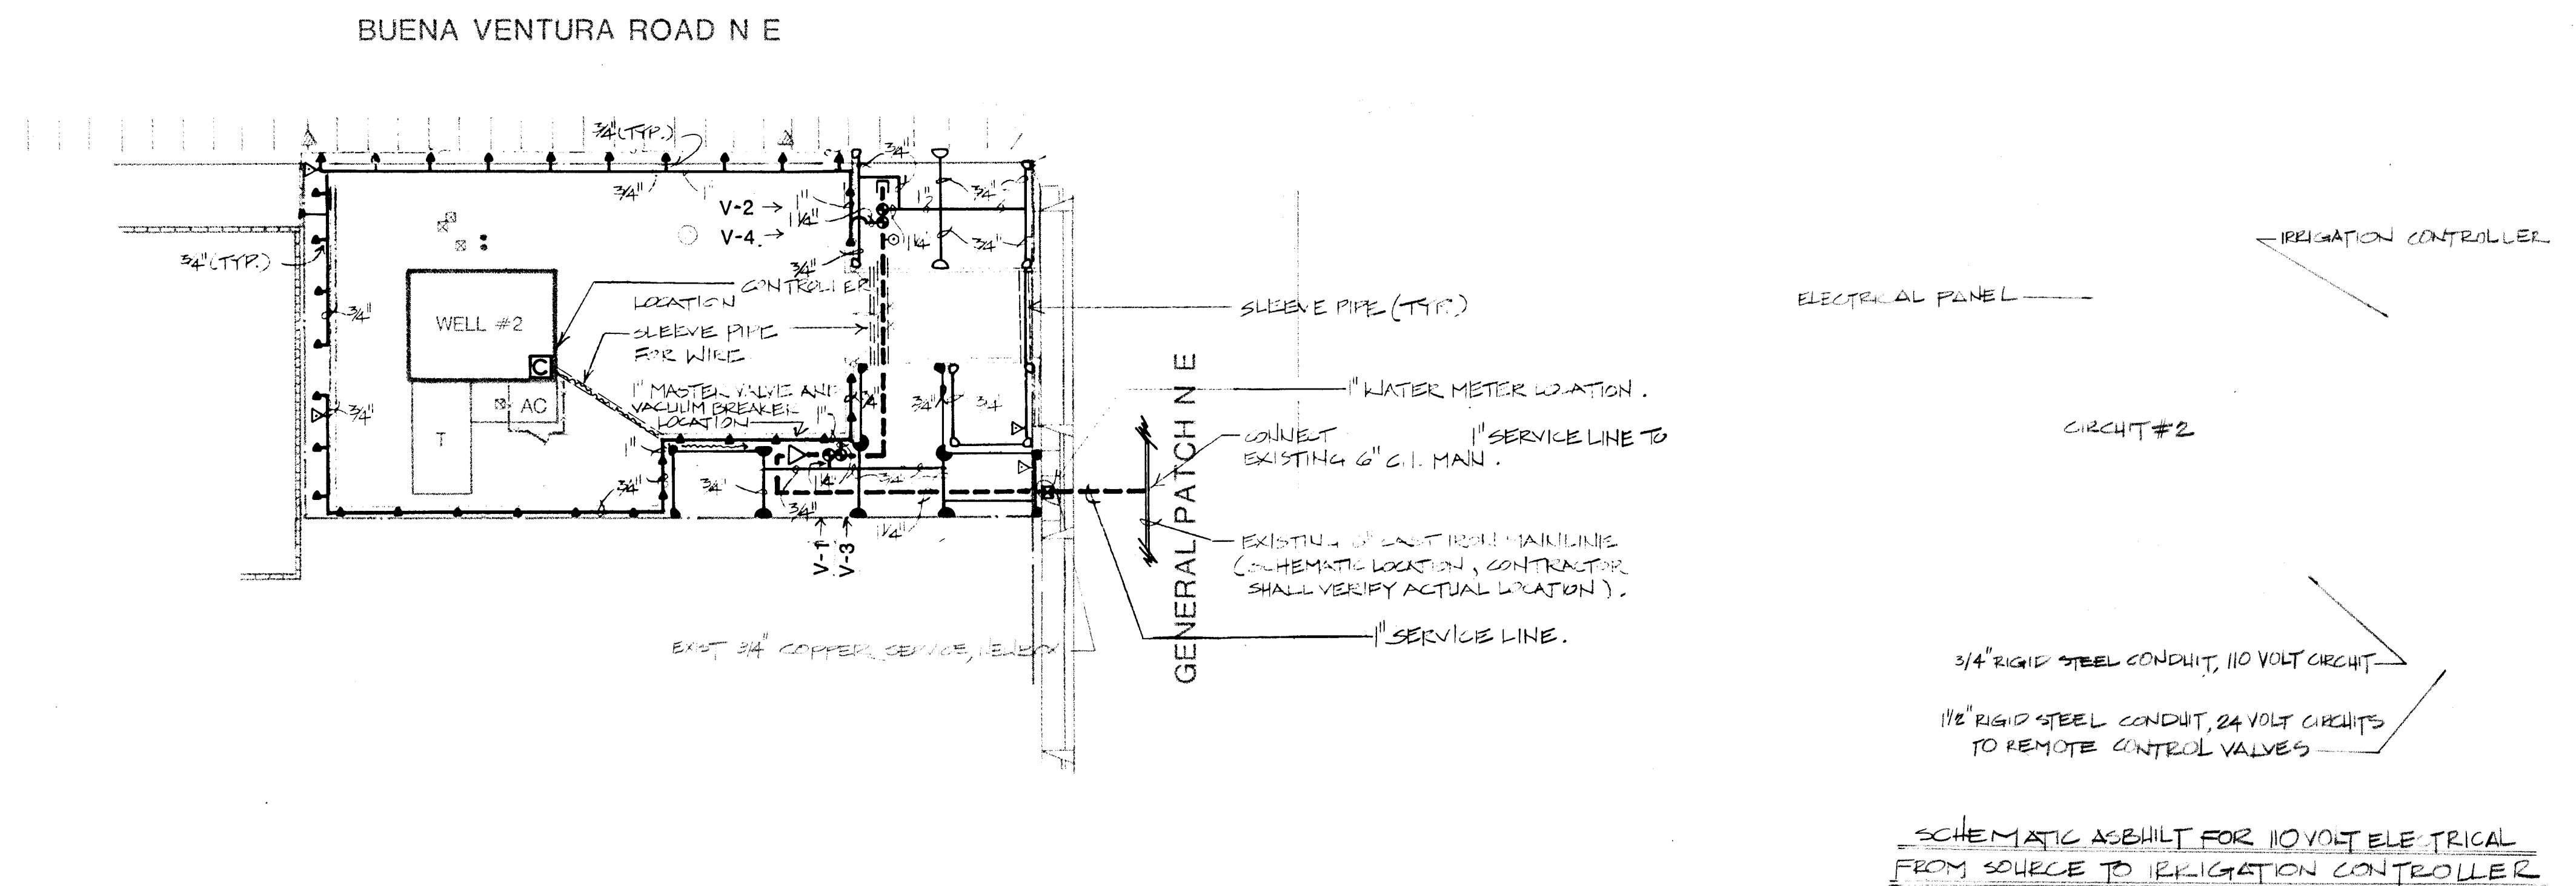

SCALE 1"=20'-0"
0 10 20 40

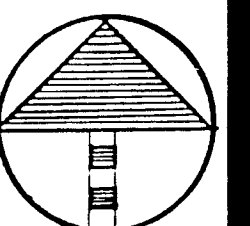

26 3097 918C

MORROW & COMPANY
LANDSCAPE ARCHITECTS
210 La Veta Drive NE
Albuquerque, New Mexico 87108
505-268-2266


NOVEMBER
1986

AS BUILT


RIDGECREST WELL #2
125 GENERAL PATCH
IRRIGATION PLAN

LANDSCAPING IMPROVEMENTS FOR
WATER SYSTEM FACILITY SITES
WATER SYSTEMS DIVISION
CITY OF ALBUQUERQUE, NEW MEXICO


SHEET
108
OF
172

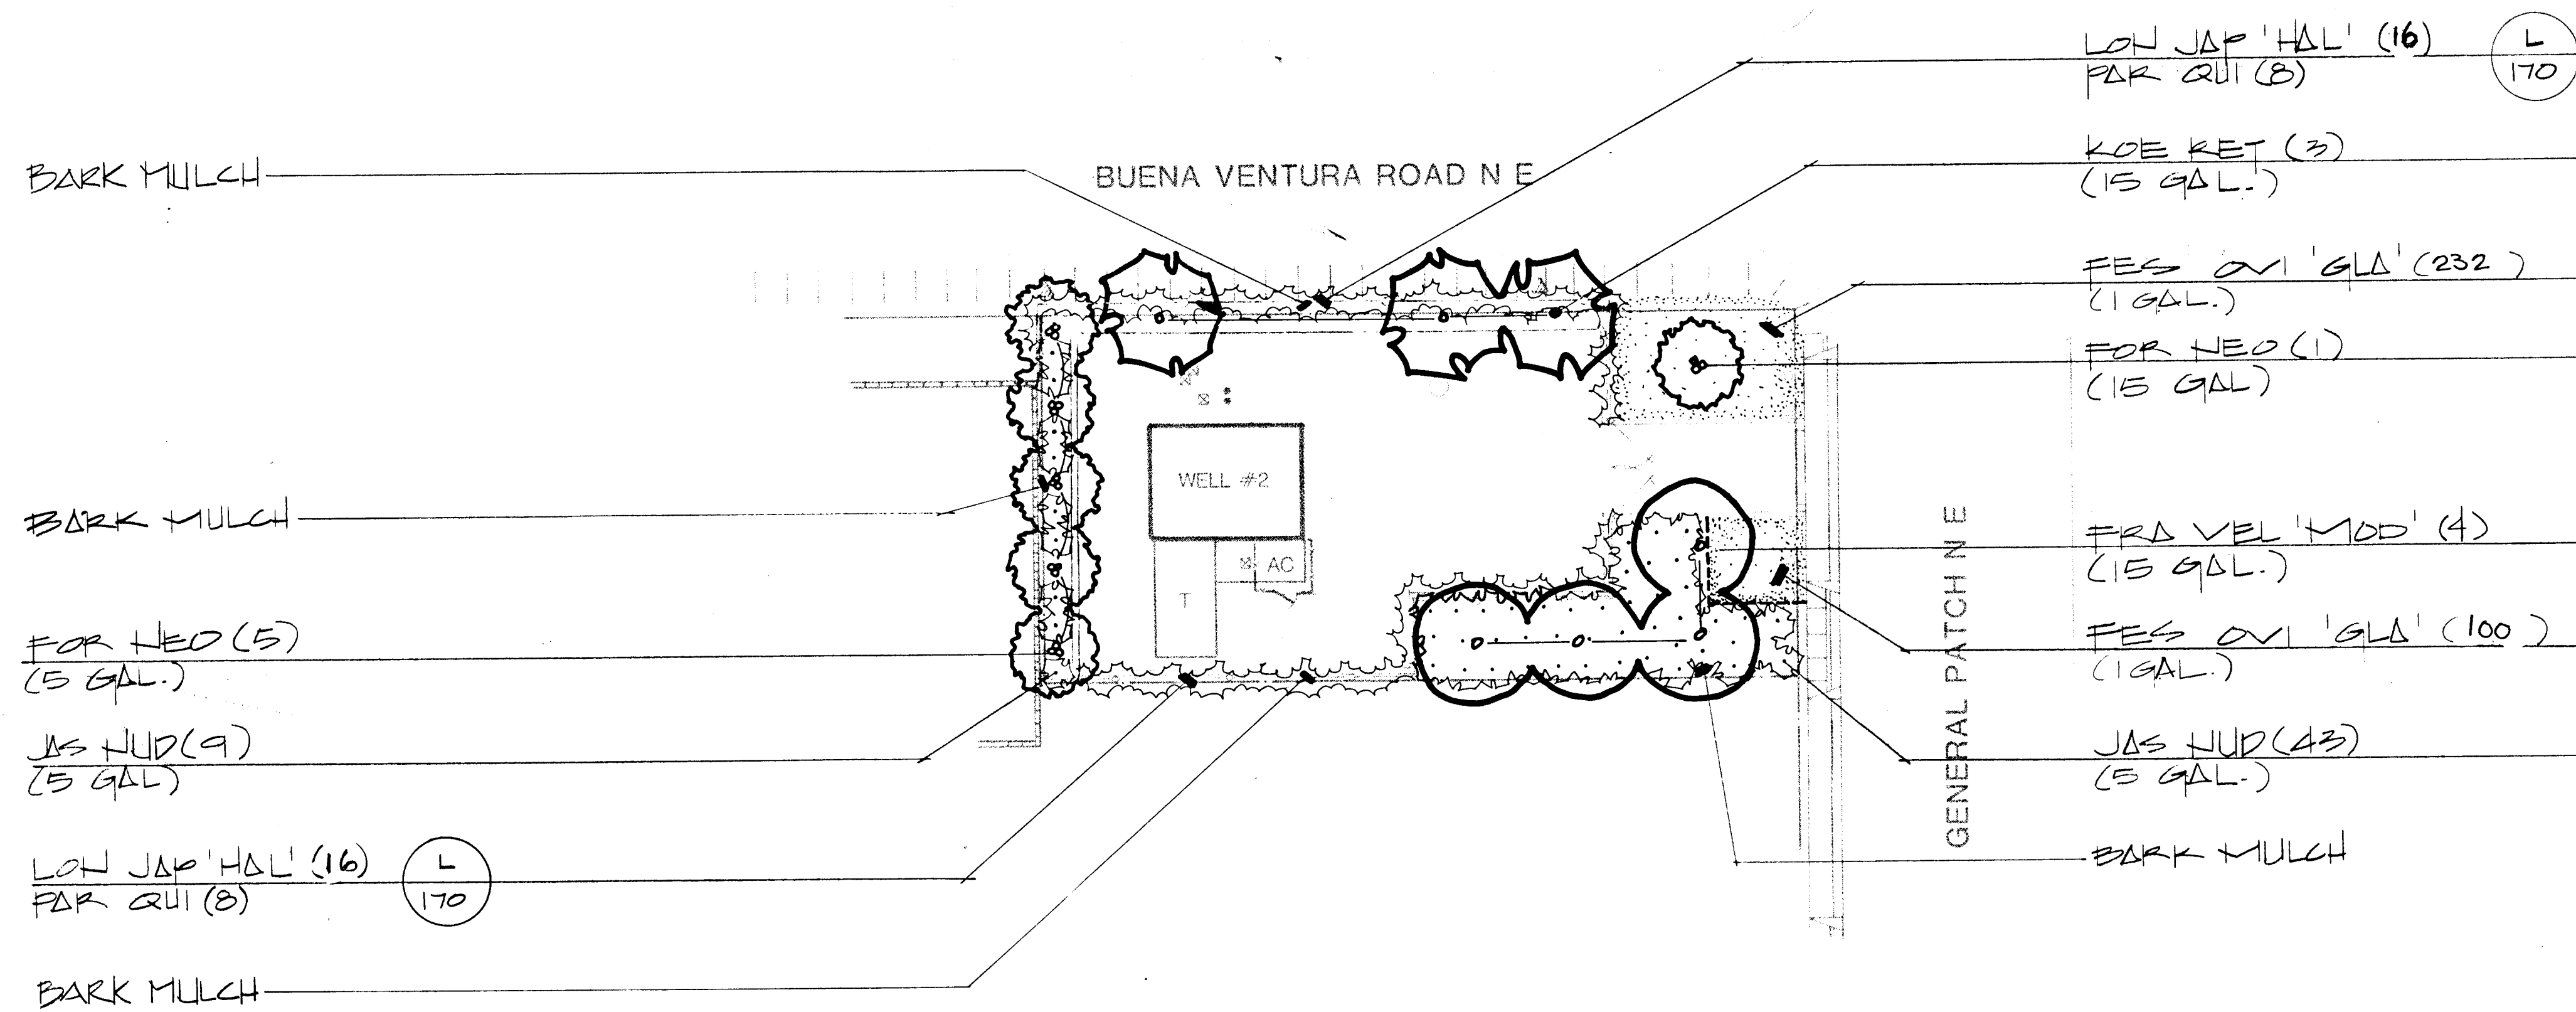


SCALE 1"=20'-0"

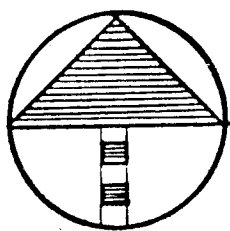

26 3097 9286

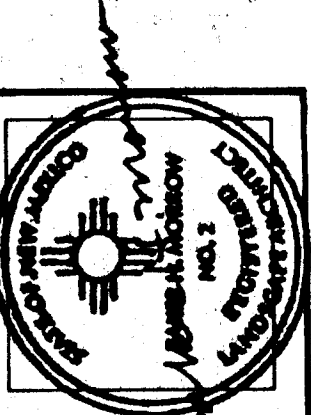

MORROW & COMPANY
LANDSCAPE ARCHITECTS
210 La Veta Drive NE
Albuquerque, New Mexico 87108
505-268-2266

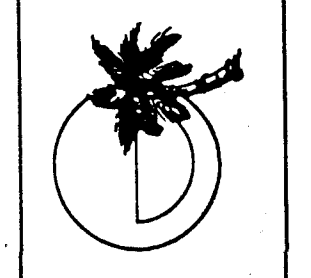



NOVEMBER
1986

AS BUILT

RIDGECREST WELL #2
125 GENERAL PATCH
PLANTING PLAN

LANDSCAPING IMPROVEMENTS FOR
WATER SYSTEM FACILITY SITES
WATER SYSTEMS DIVISION
CITY OF ALBUQUERQUE
ALBUQUERQUE, NEW MEXICO


SHEET
103
12

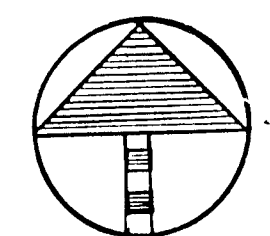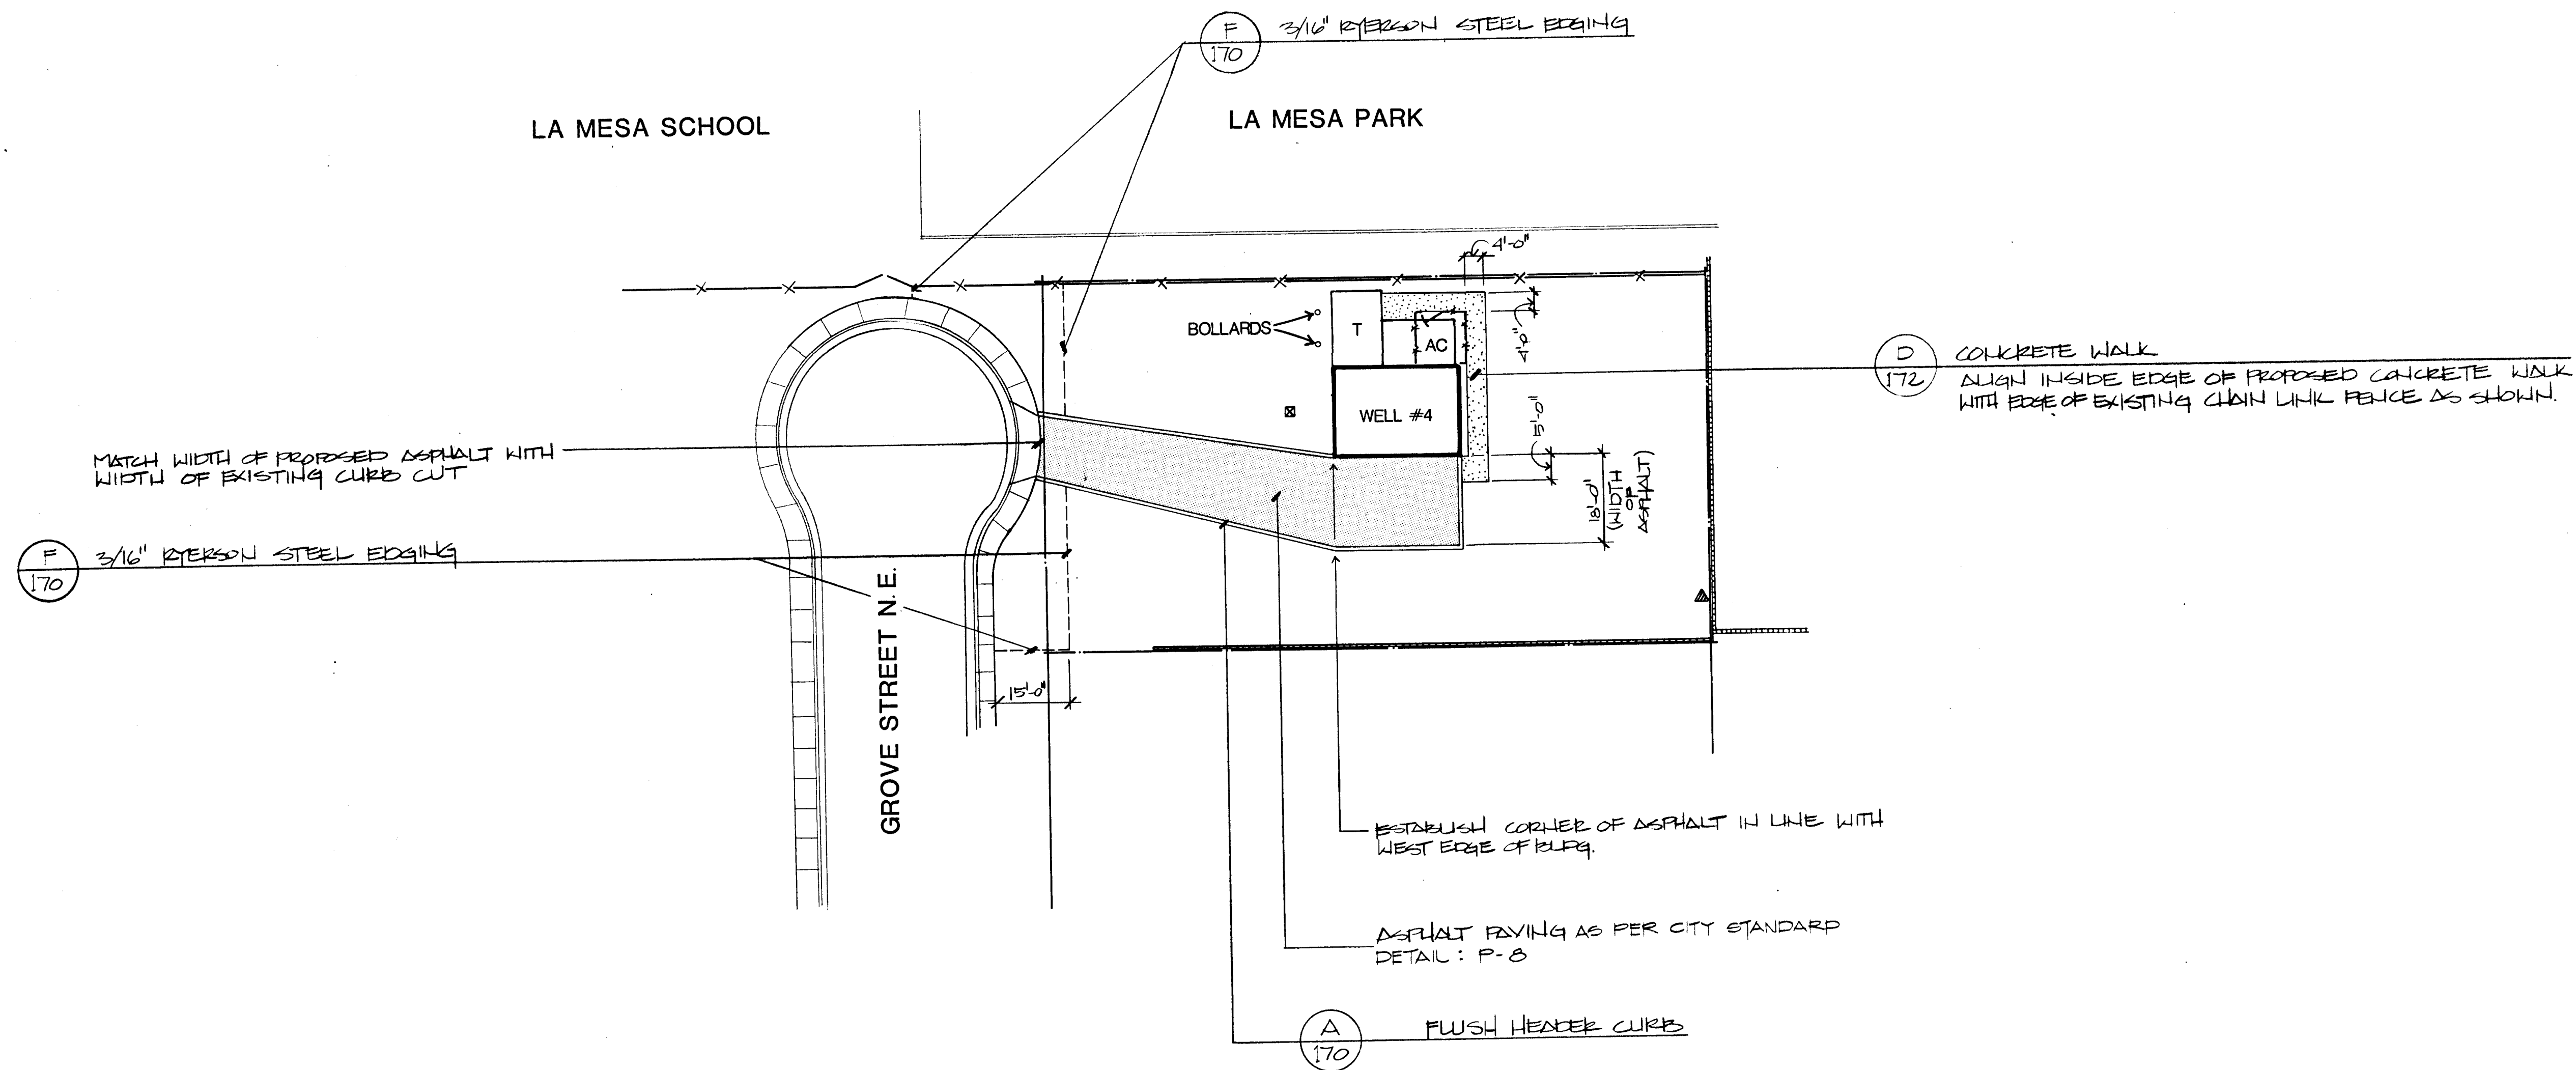


SCALE 1"=20'-0"

0 10 20 40

26 3097 9486

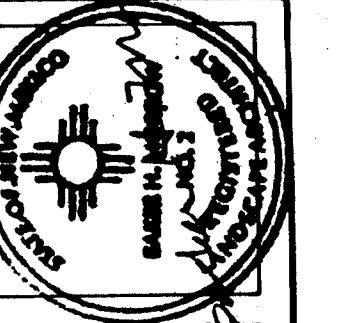

MORROW & COMPANY
LANDSCAPE ARCHITECTS
210 La Veta Drive NE
Albuquerque, New Mexico 87108
505-268-2266

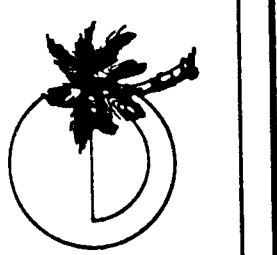

NOVEMBER
1986

AS BUILT




RIDGECREST WELL #4
324 GROVE NE
CONSTRUCTION PLAN

LANDSCAPING IMPROVEMENTS FOR
WATER SYSTEM FACILITY SITES
WATER SYSTEMS DIVISION
CITY OF ALBUQUERQUE
ALBUQUERQUE, NEW MEXICO


SHEET
172

LA MESA SCHOOL

LA MESA PARK

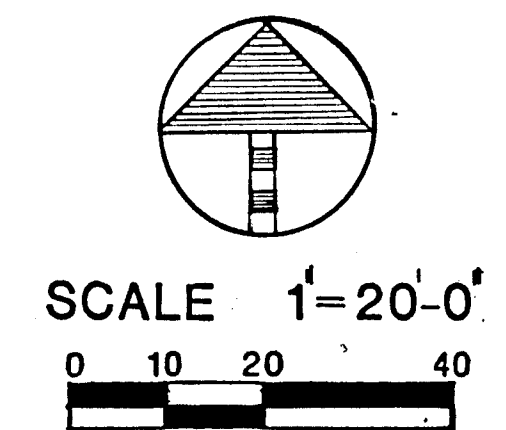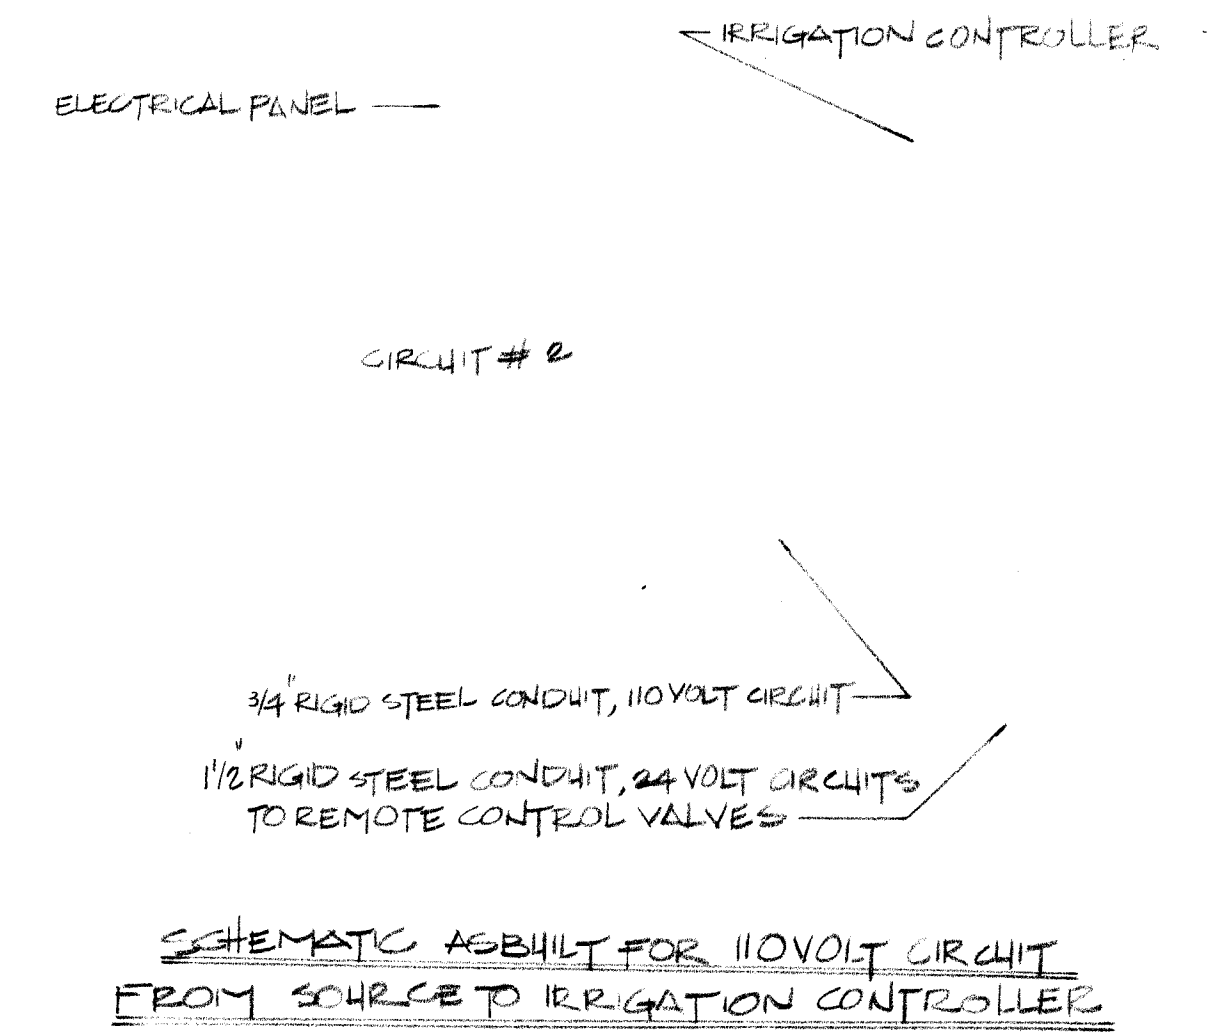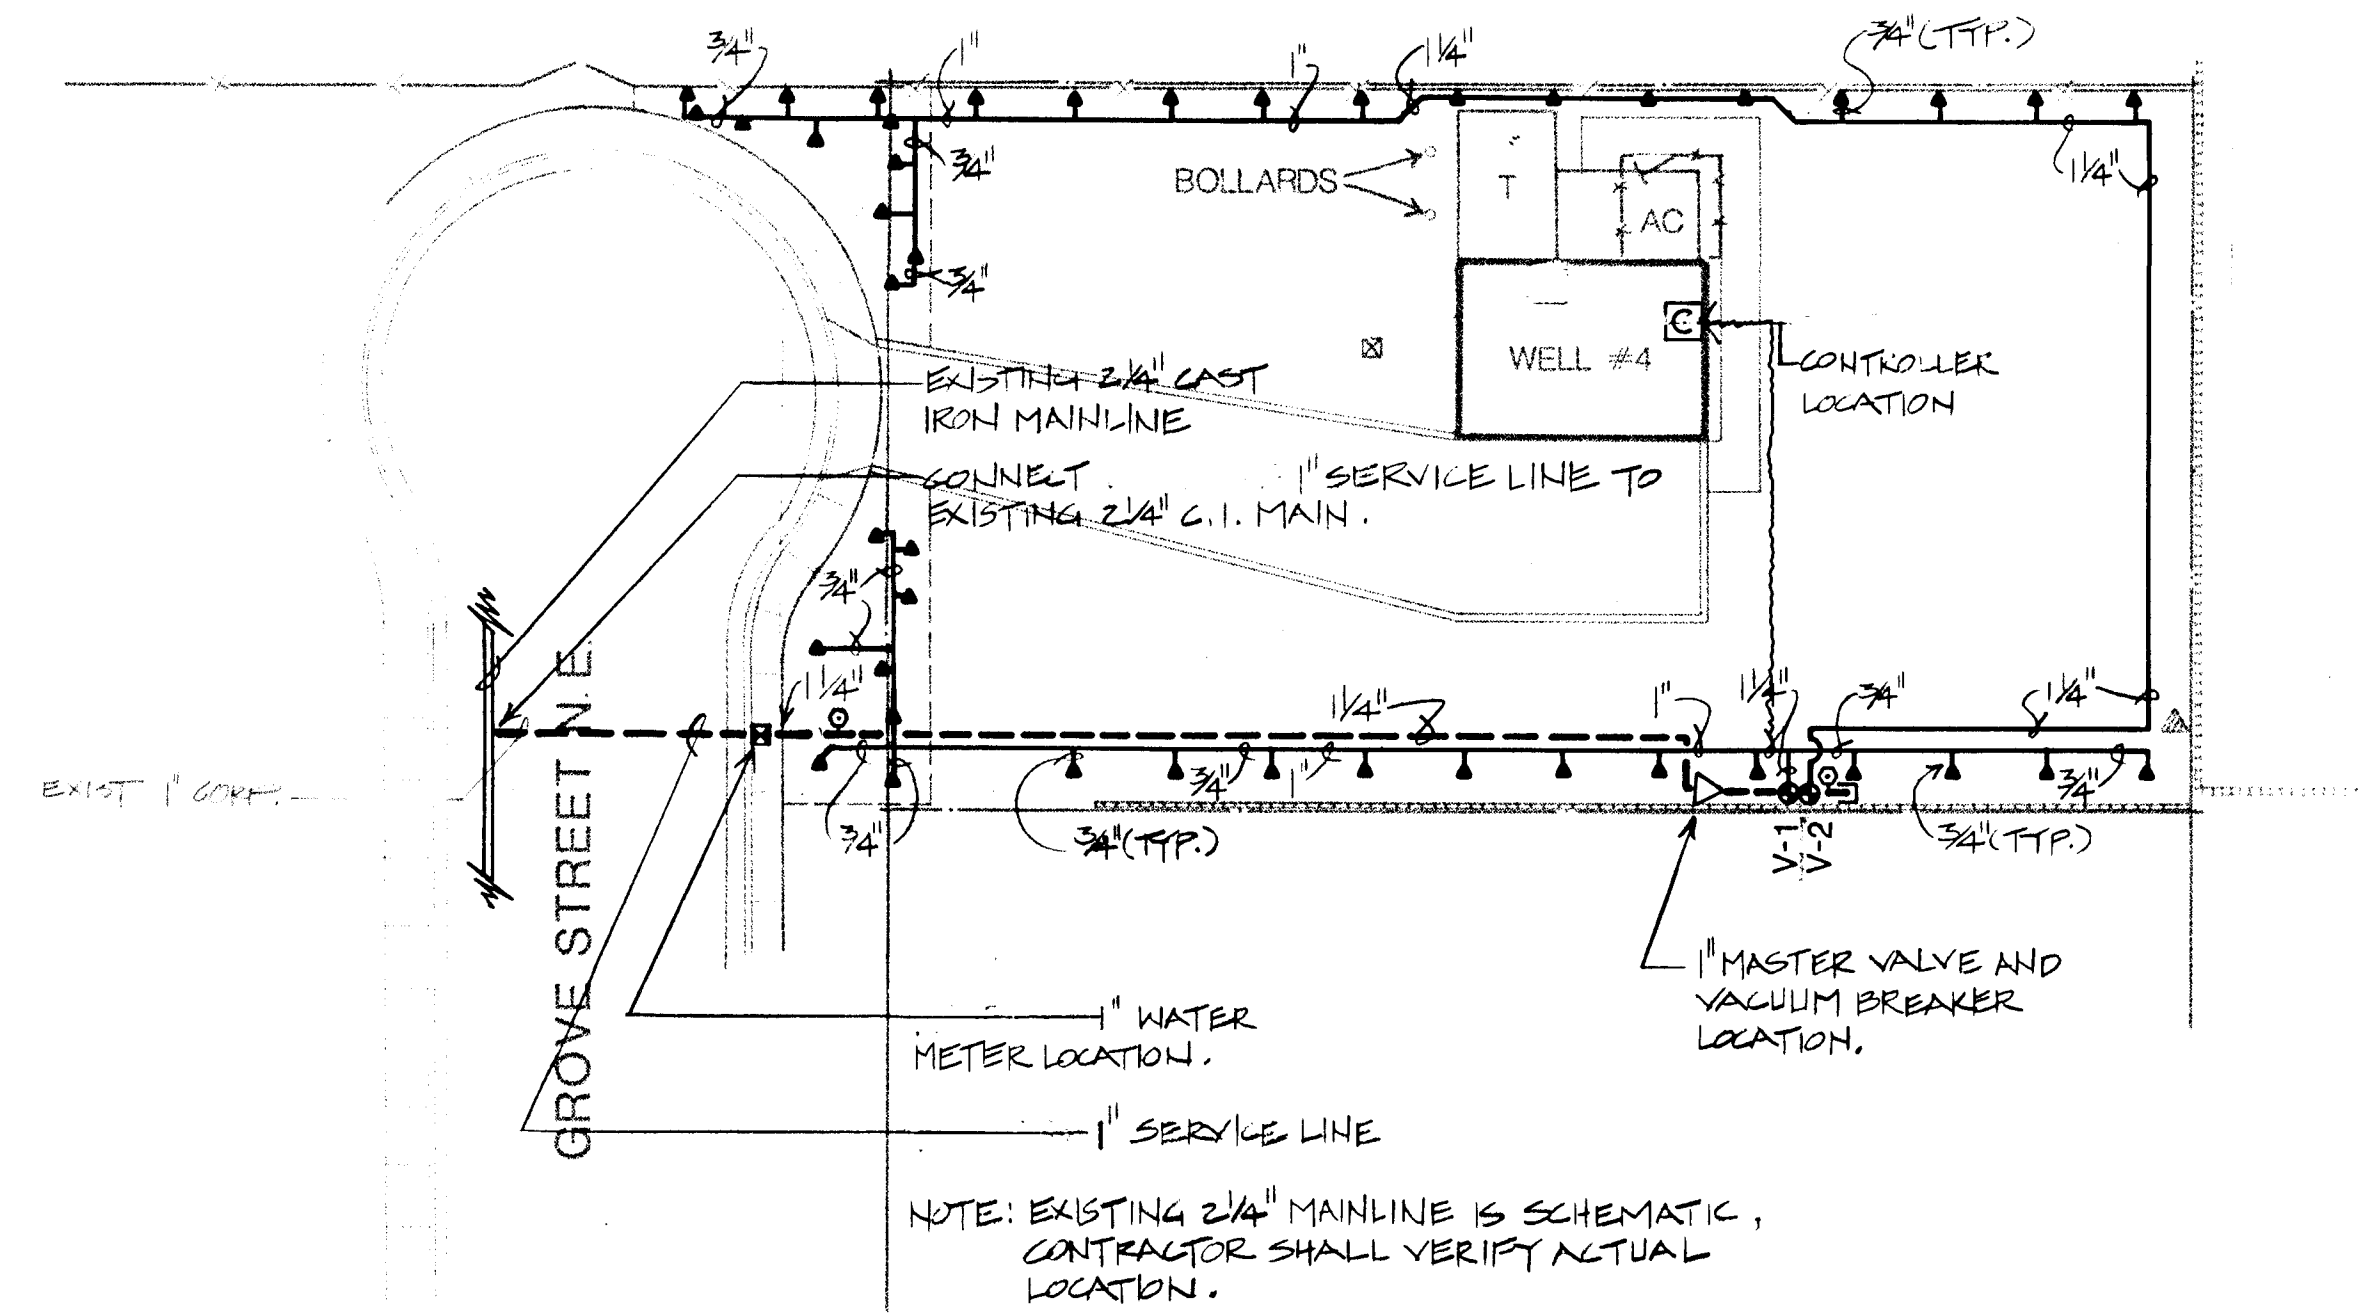

26 3097 9586

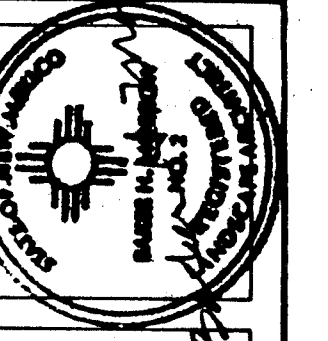

MORROW & COMPANY
LANDSCAPE ARCHITECTS
210 La Veta Drive NE
Albuquerque, New Mexico 87108
505-268-2266





NOVEMBER
1986


AS BUILT
RIDGECREST WELL #4
324 GROVE NE
IRRIGATION PLAN

LANDSCAPING IMPROVEMENTS FOR
WATER SYSTEM FACILITY SITES
WATER SYSTEMS DIVISION
CITY OF ALBUQUERQUE
ALBUQUERQUE, NEW MEXICO


SHEET
112
01
172

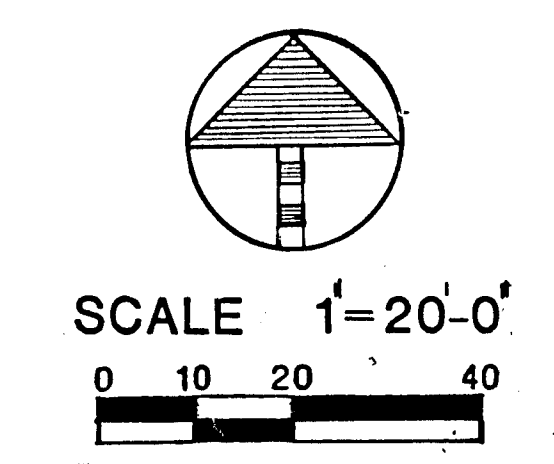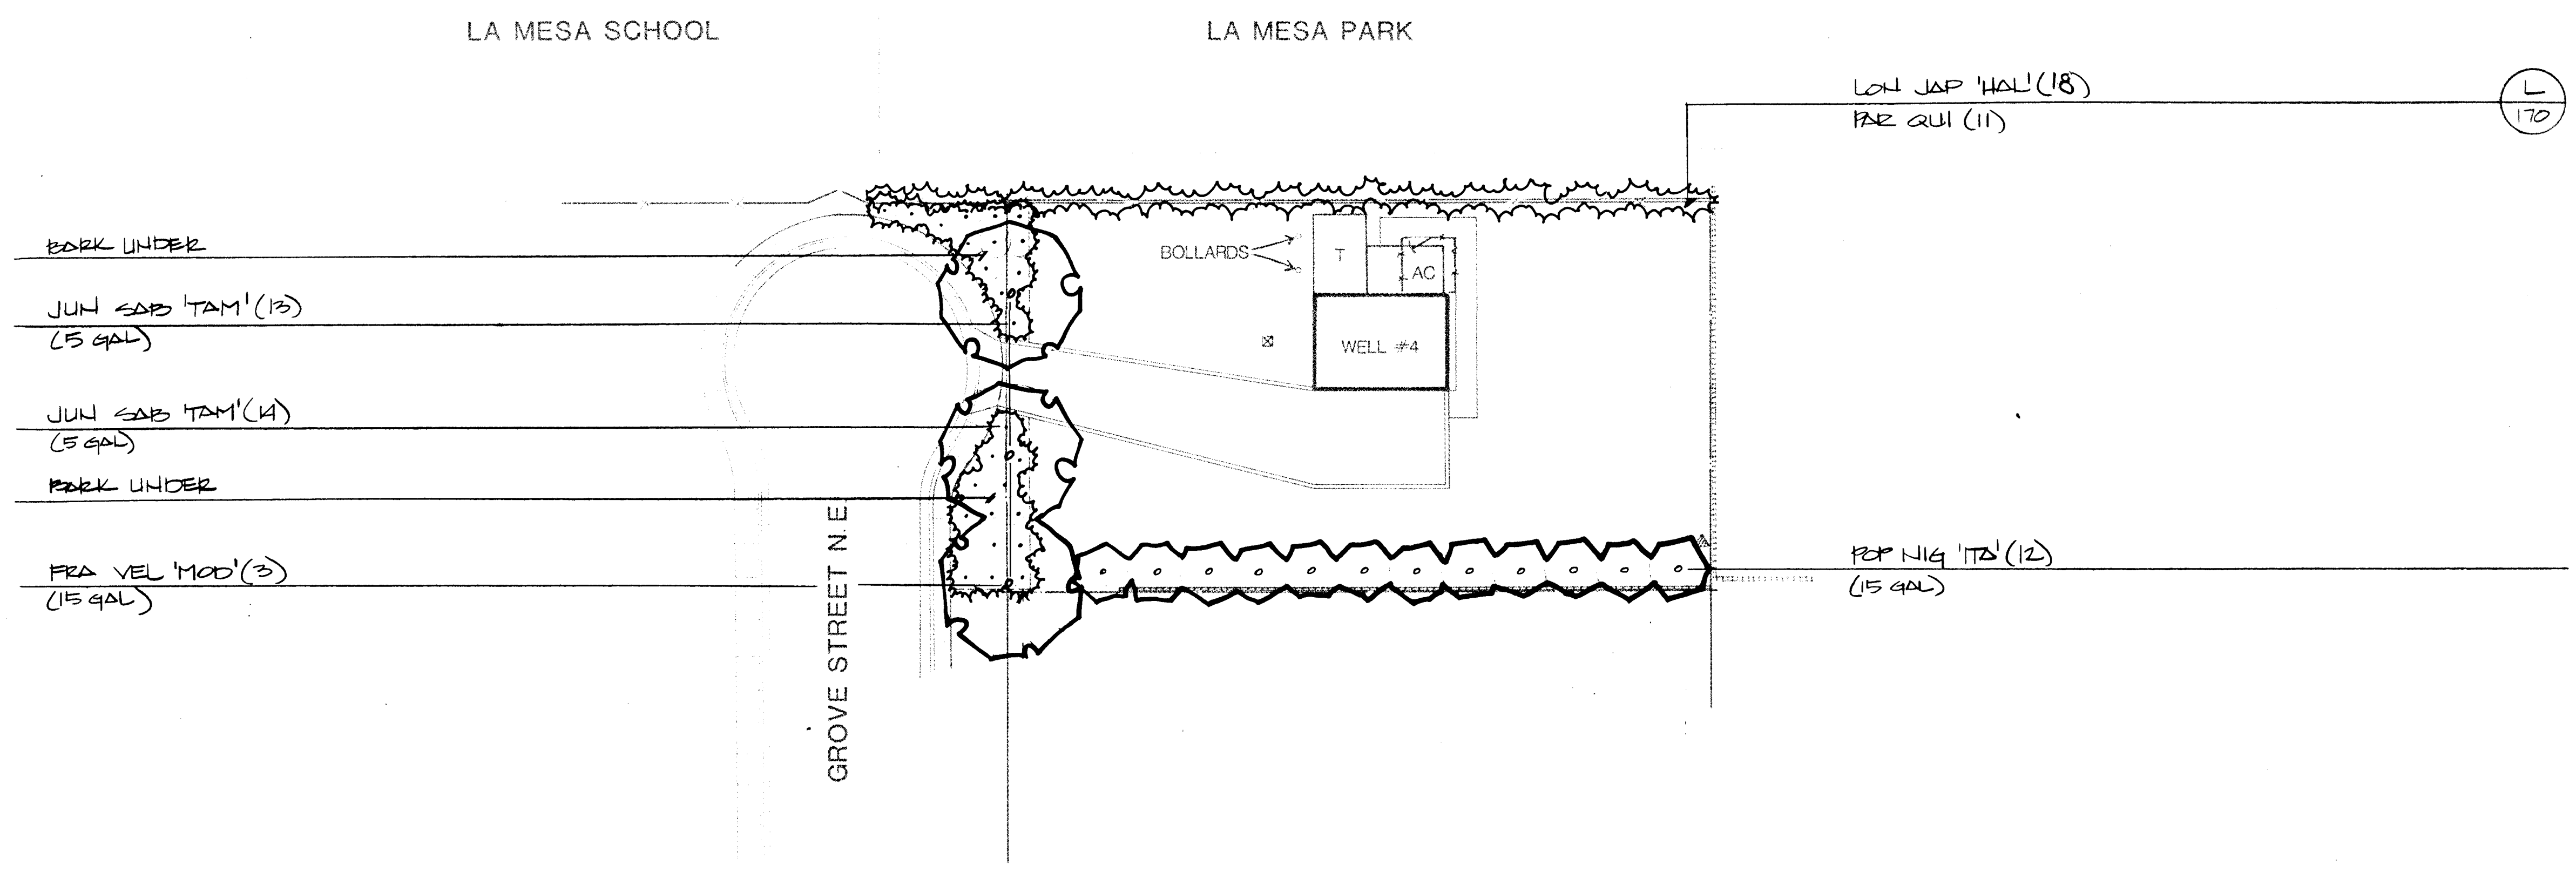

26 3097 9686

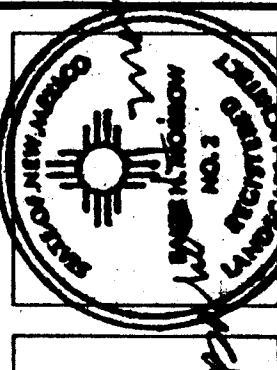
 MORROW & COMPANY LANDSCAPE ARCHITECTS 210 La Veta Drive NE Albuquerque, New Mexico 87108 505-268-2266	NOVEMBER 1986 AS BUILT RIDGECREST WELL #4 324 GROVE NE PLANTING PLAN	LANDSCAPING IMPROVEMENTS FOR WATER SYSTEM FACILITY SITES WATER SYSTEMS DIVISION CITY OF ALBUQUERQUE ALBUQUERQUE, NEW MEXICO SHEET 13 OF 172
--	--	---

CHAINLINK FENCE TO BE RECONSTRUCTED
AT NEW GRADE BETWEEN POINTS "A" AND "B"
(REFER TO CONSTRUCTION PLAN)

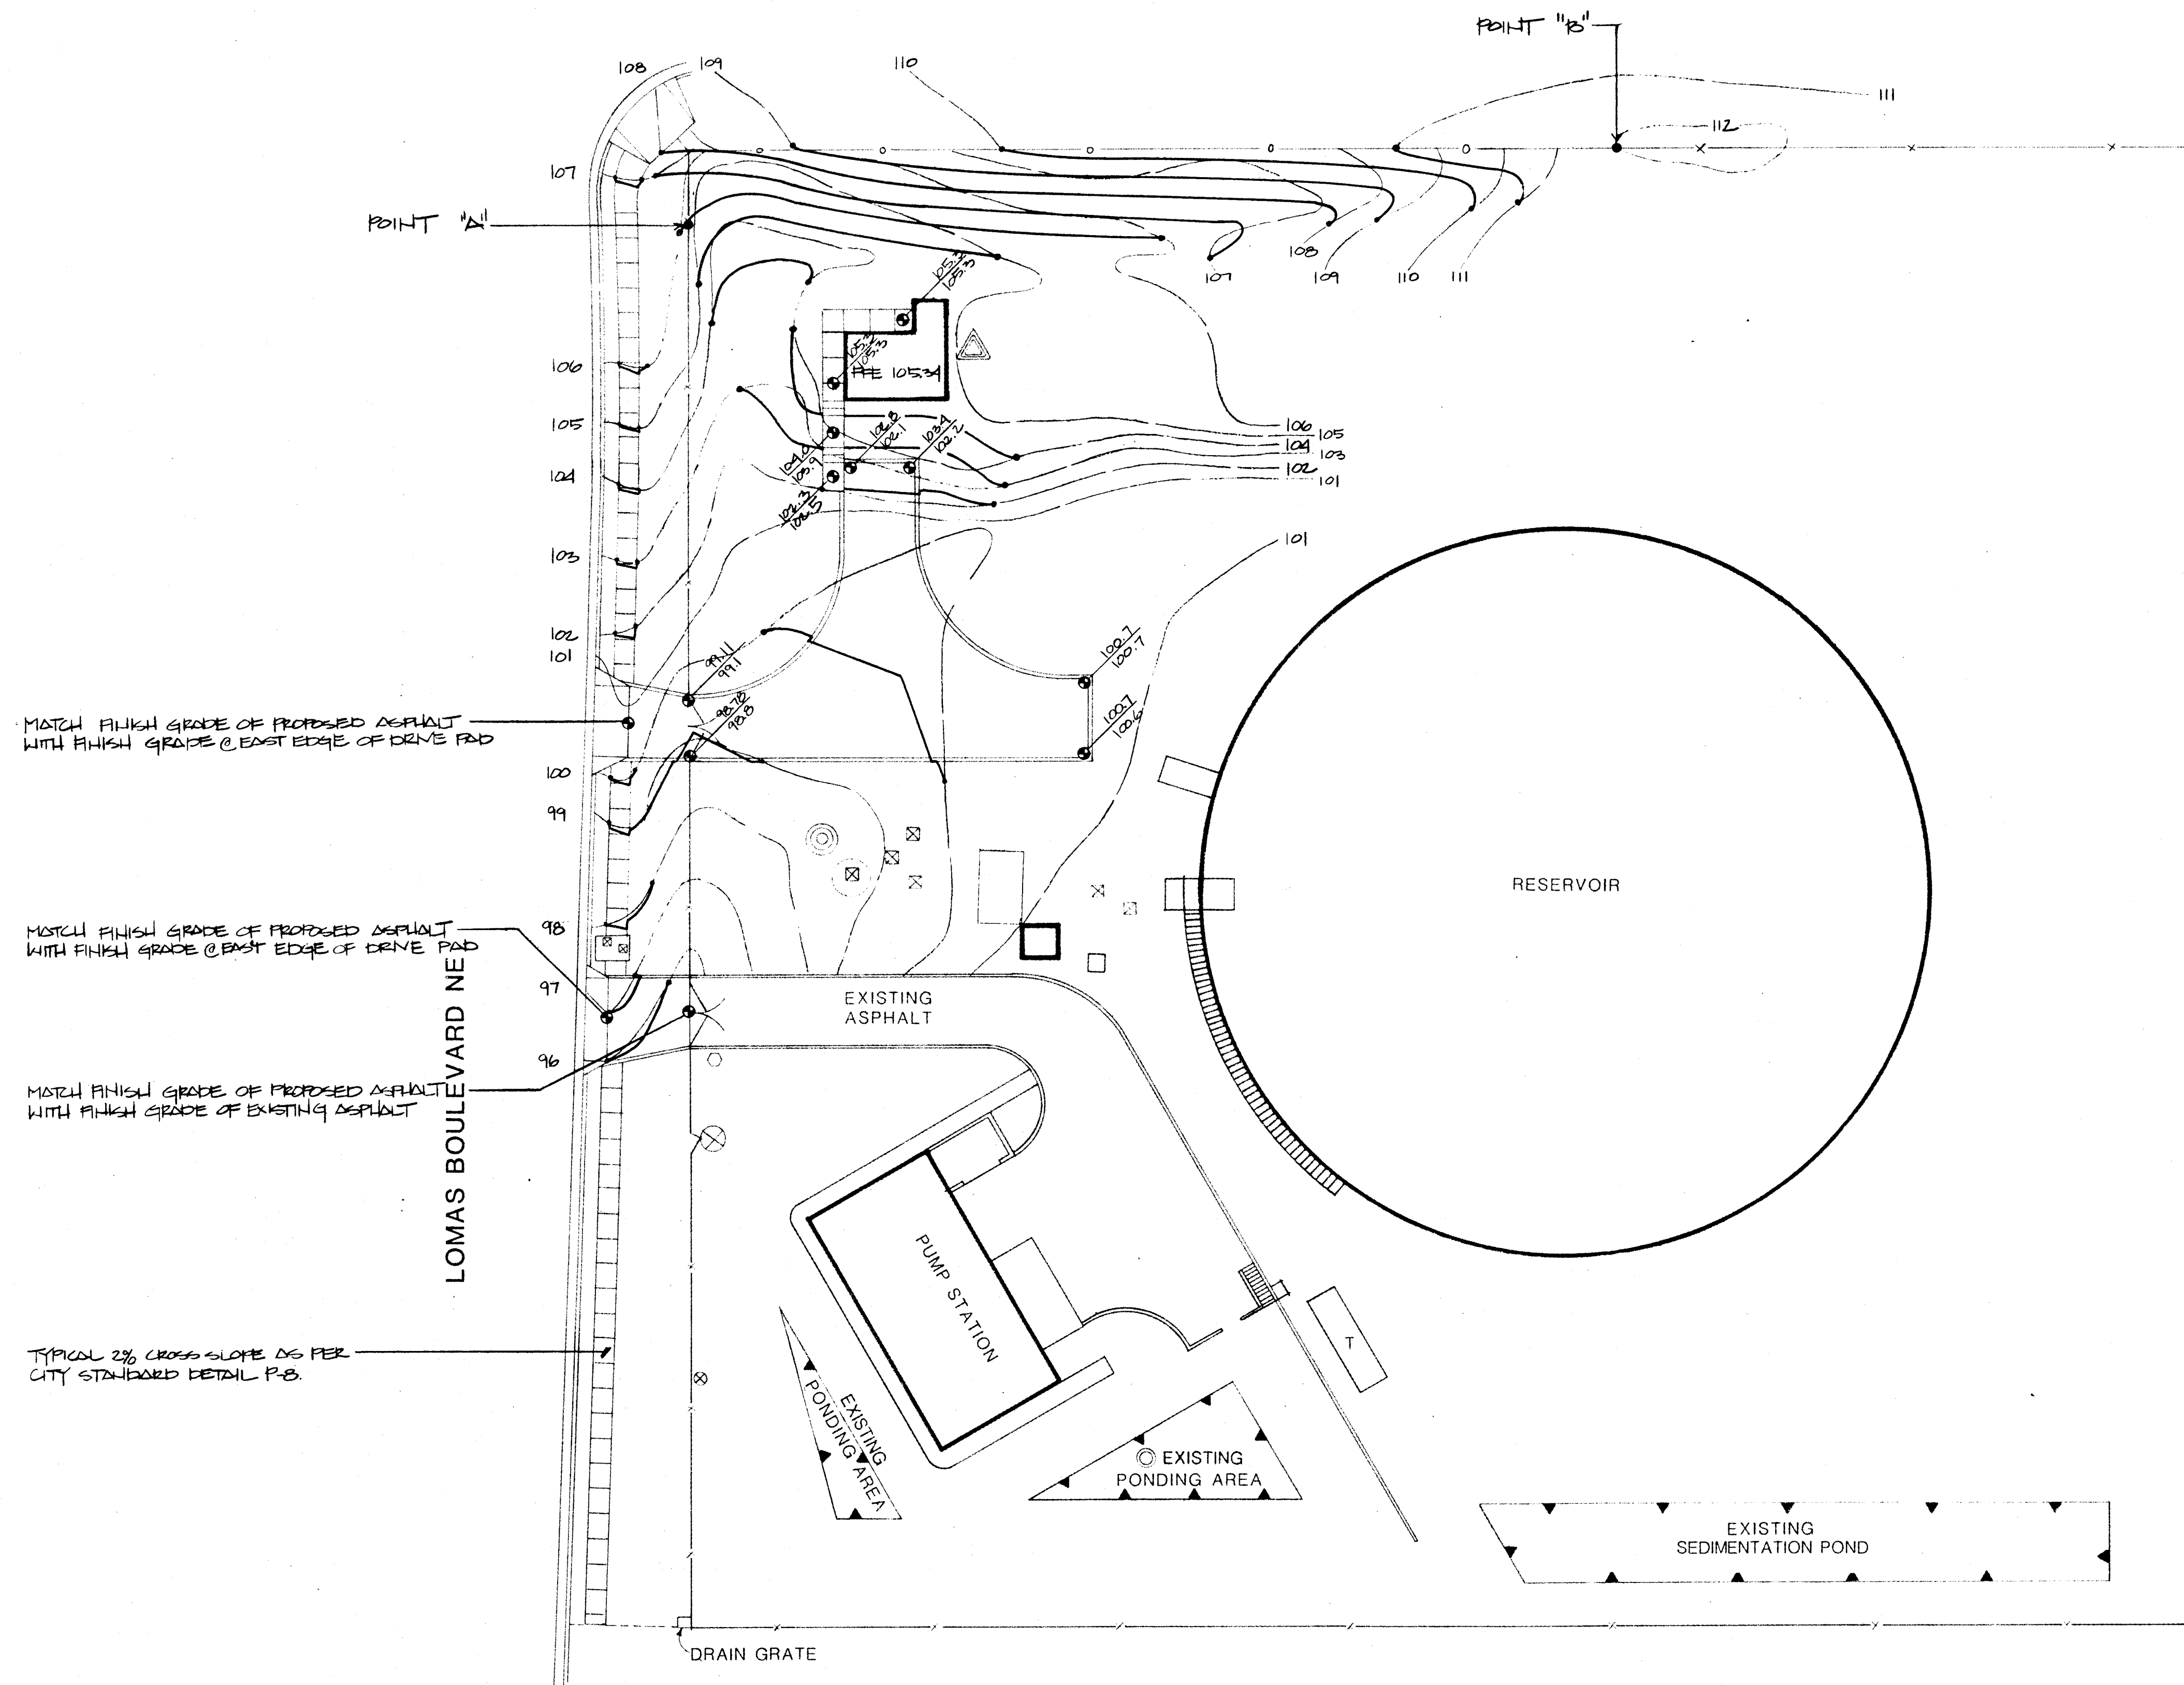


SCALE 1"=20'-0"

26 3097 9786

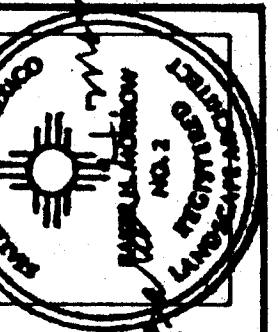

MORROW & COMPANY
LANDSCAPE ARCHITECTS
210 La Veta Drive NE
Albuquerque, New Mexico 87108
505-268-2266

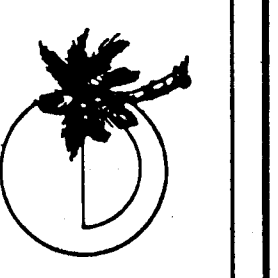





NOVEMBER
1986

SANDIA MANOR RESERVOIR & PUMP STATION
15000 LOMAS BOULEVARD NE
GRADING PLAN
AS BUILT

LANDSCAPING IMPROVEMENTS FOR
WATER SYSTEM FACILITY SITES
WATER SYSTEMS DIVISION
CITY OF ALBUQUERQUE
ALBUQUERQUE, NEW MEXICO

SHEET
04
172

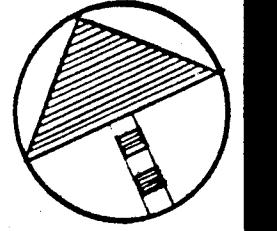

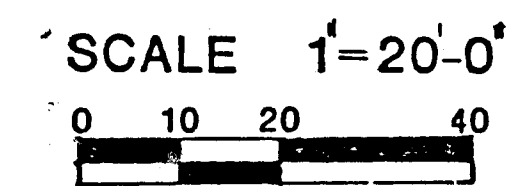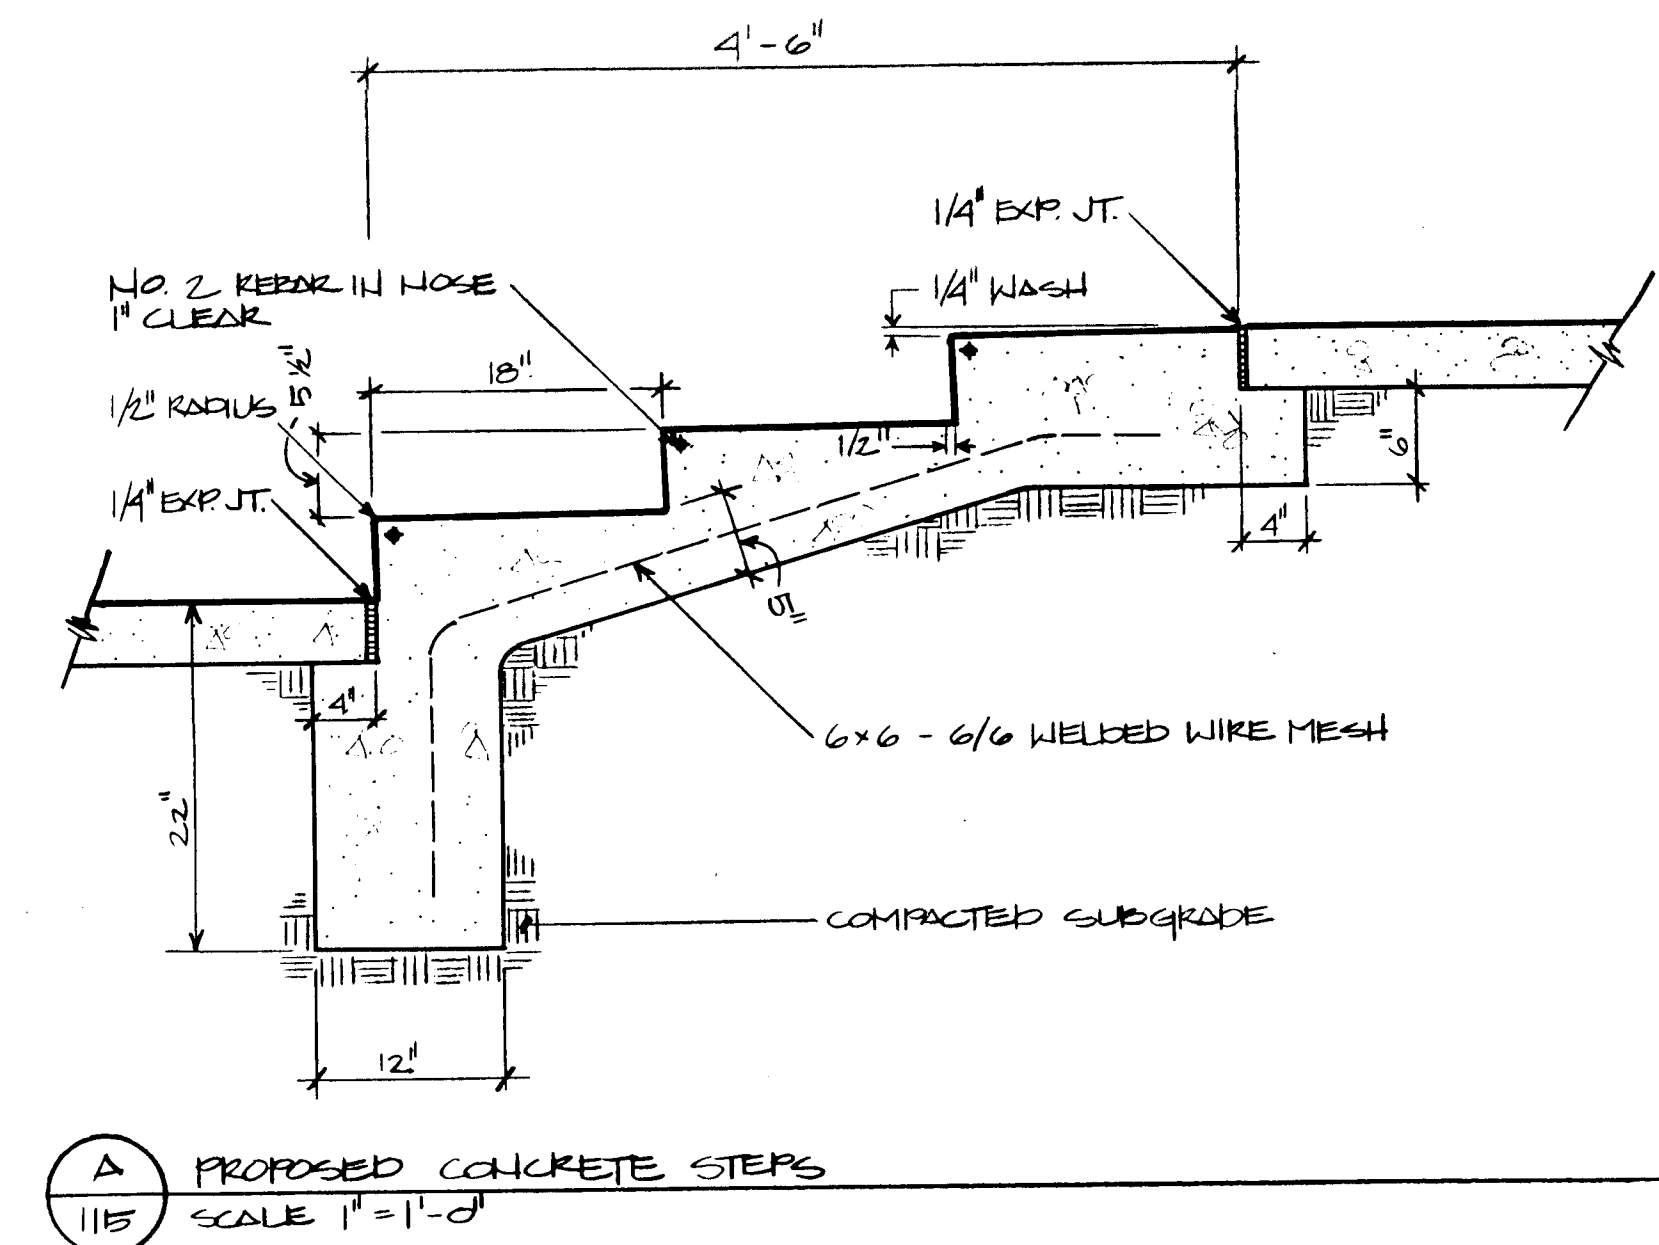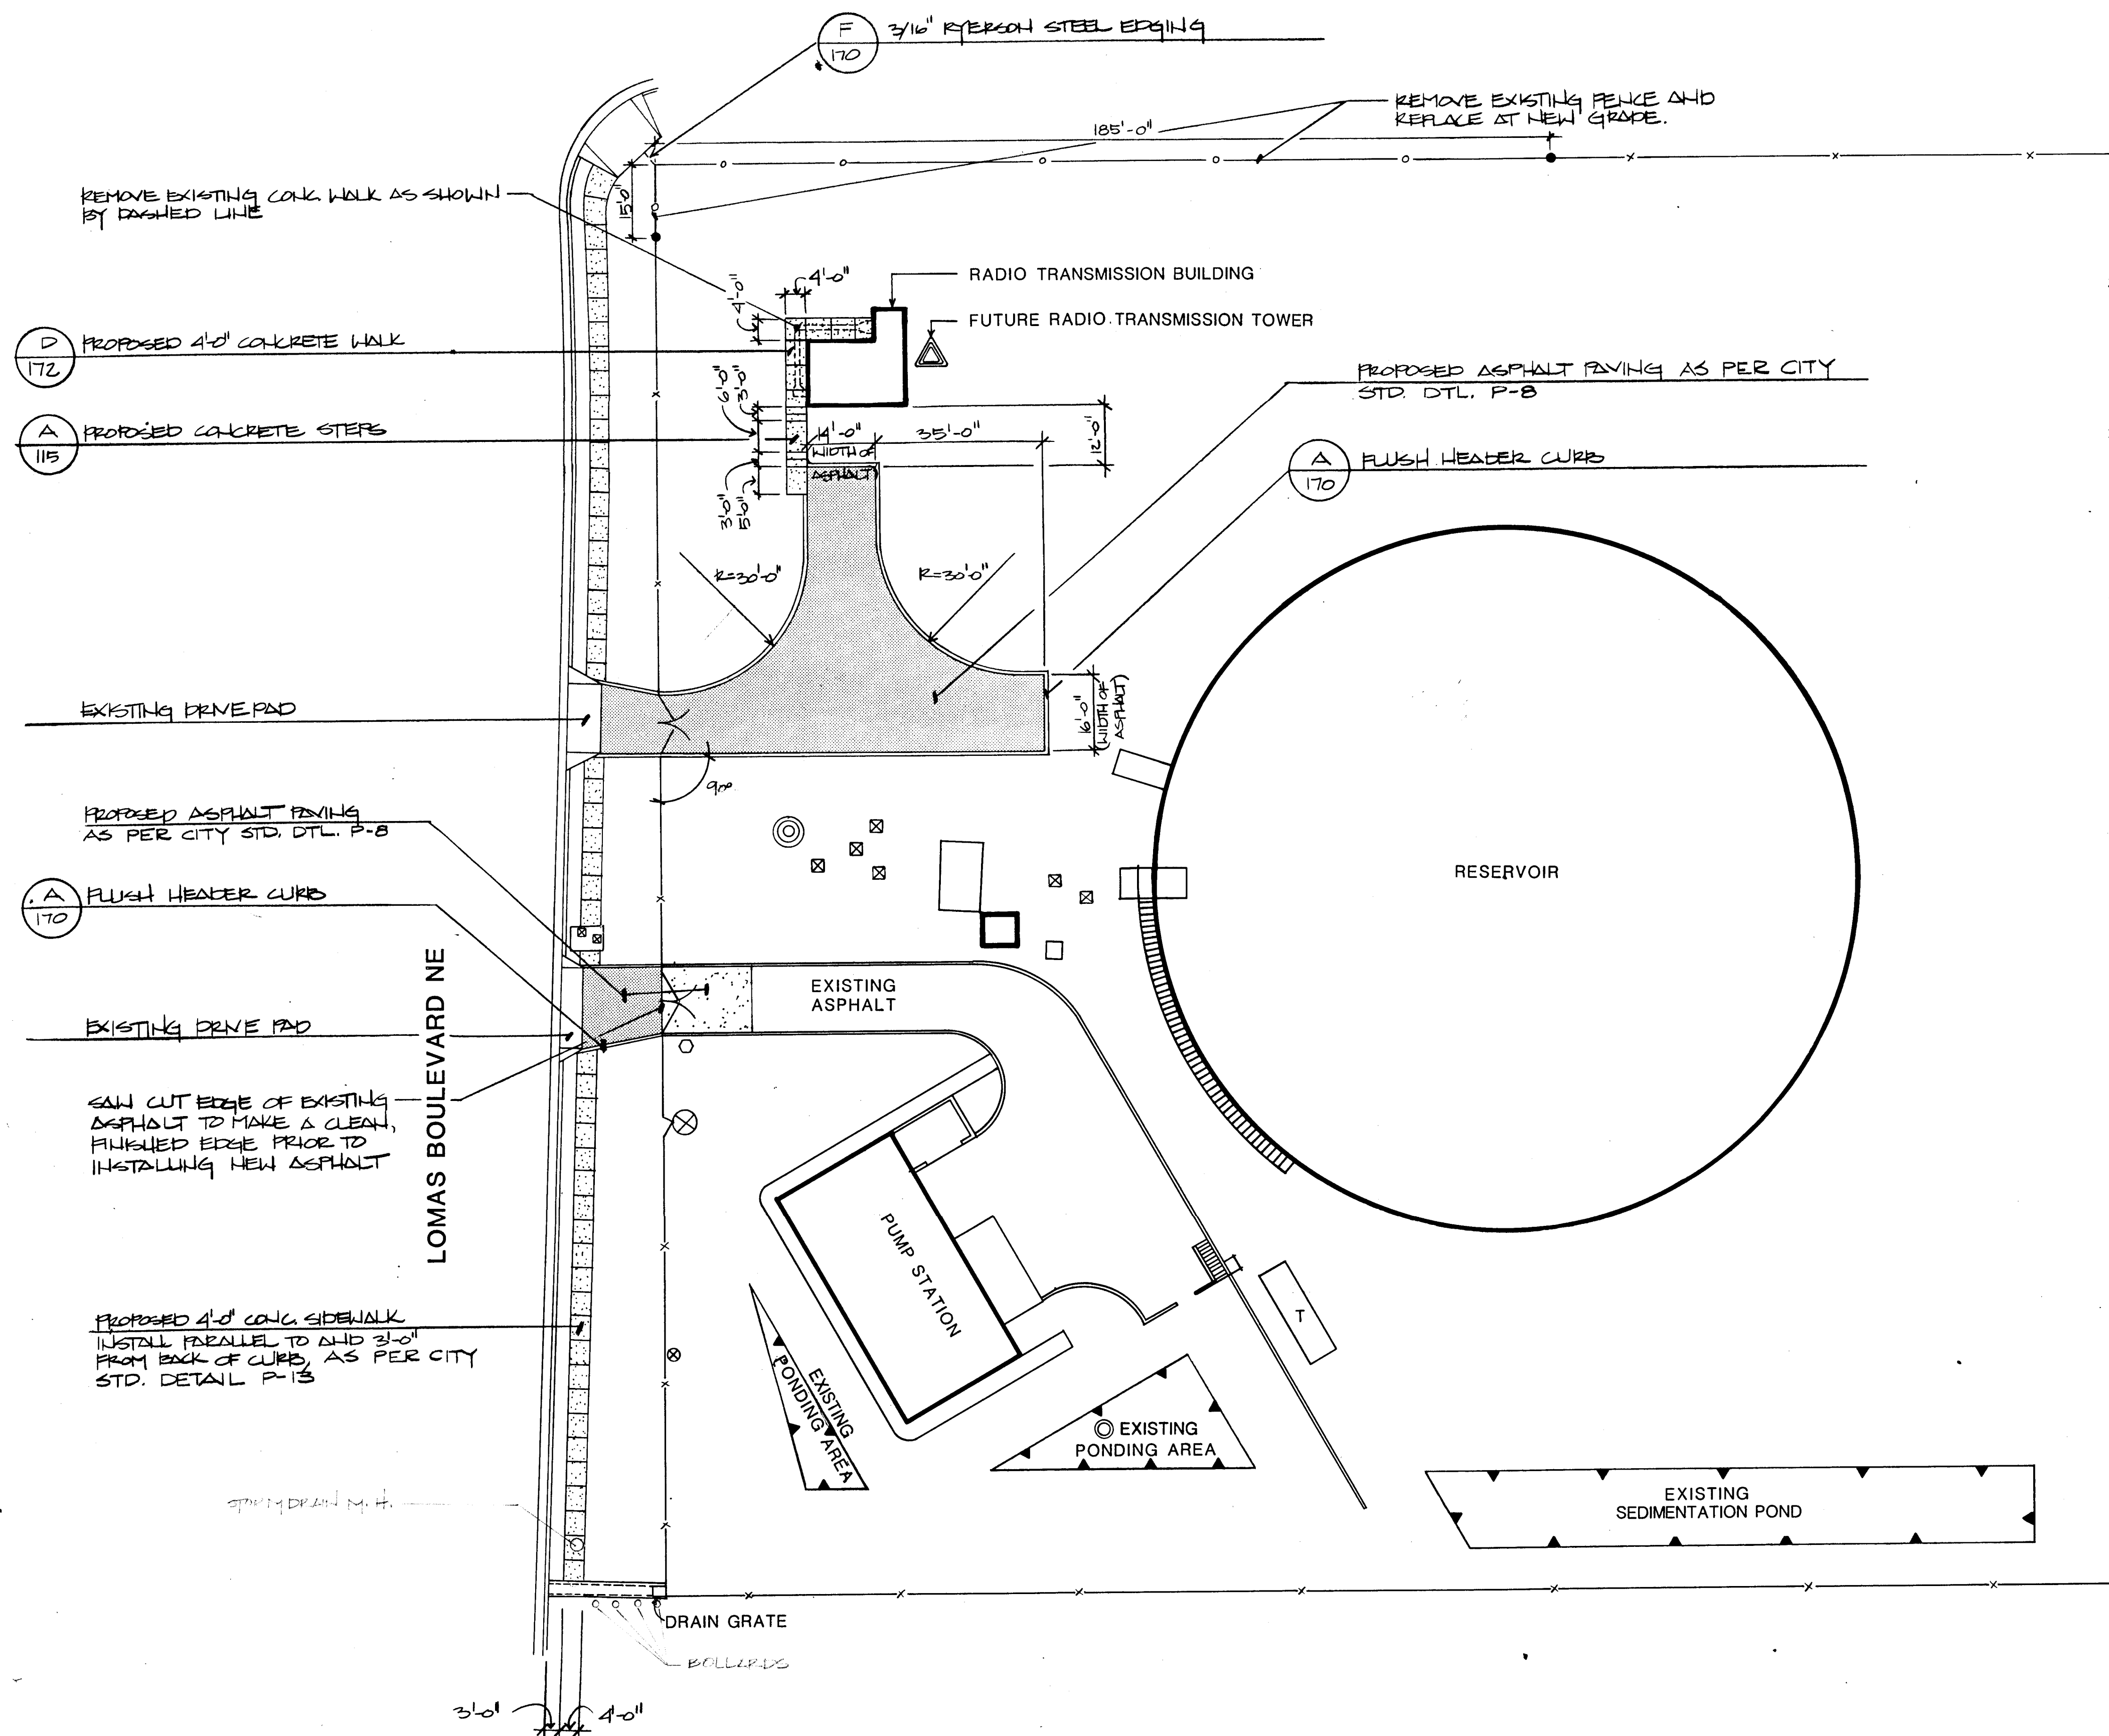

LANDSCAPING IMPROVEMENTS FOR
WATER SYSTEM FACILITY SITES
CITY OF ALBUQUERQUE
ALBUQUERQUE, NEW MEXICO

AS BUILT


SANDIA MANOR RESERVOIR & PUMP STATION
15000 LOMAS BOULEVARD NE
CONSTRUCTION PLAN

MORROW & COMPANY
LANDSCAPE ARCHITECTS
210 La Veta Drive NE
Albuquerque, New Mexico 87108
505-268-2266


NOVEMBER 1986


SHEET
172

26 3097 9886

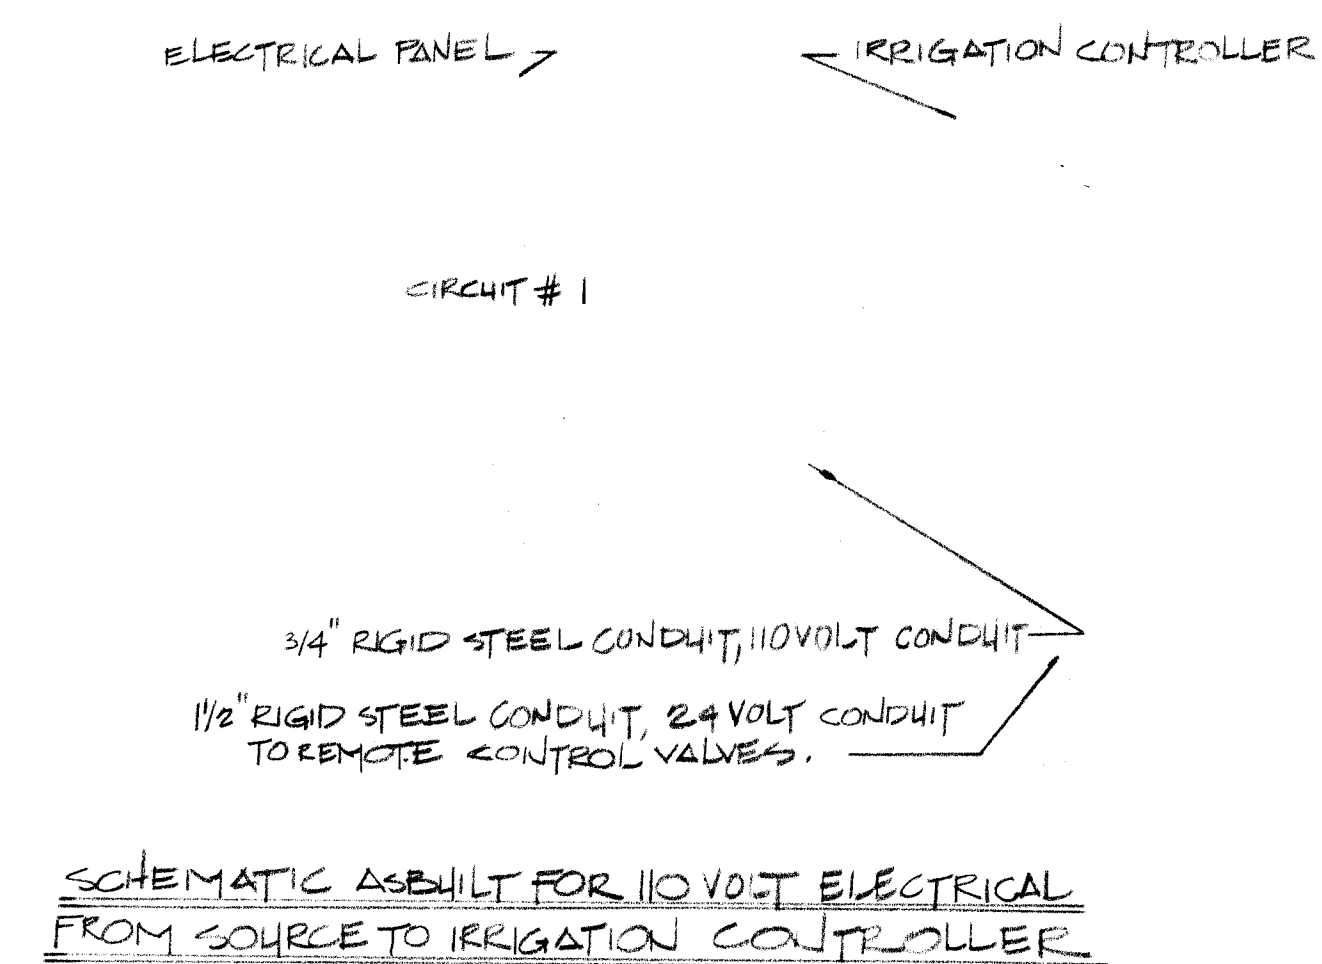

SCALE 1"=20'-0"

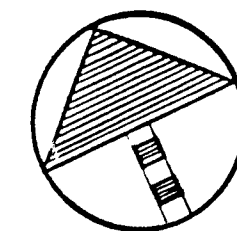


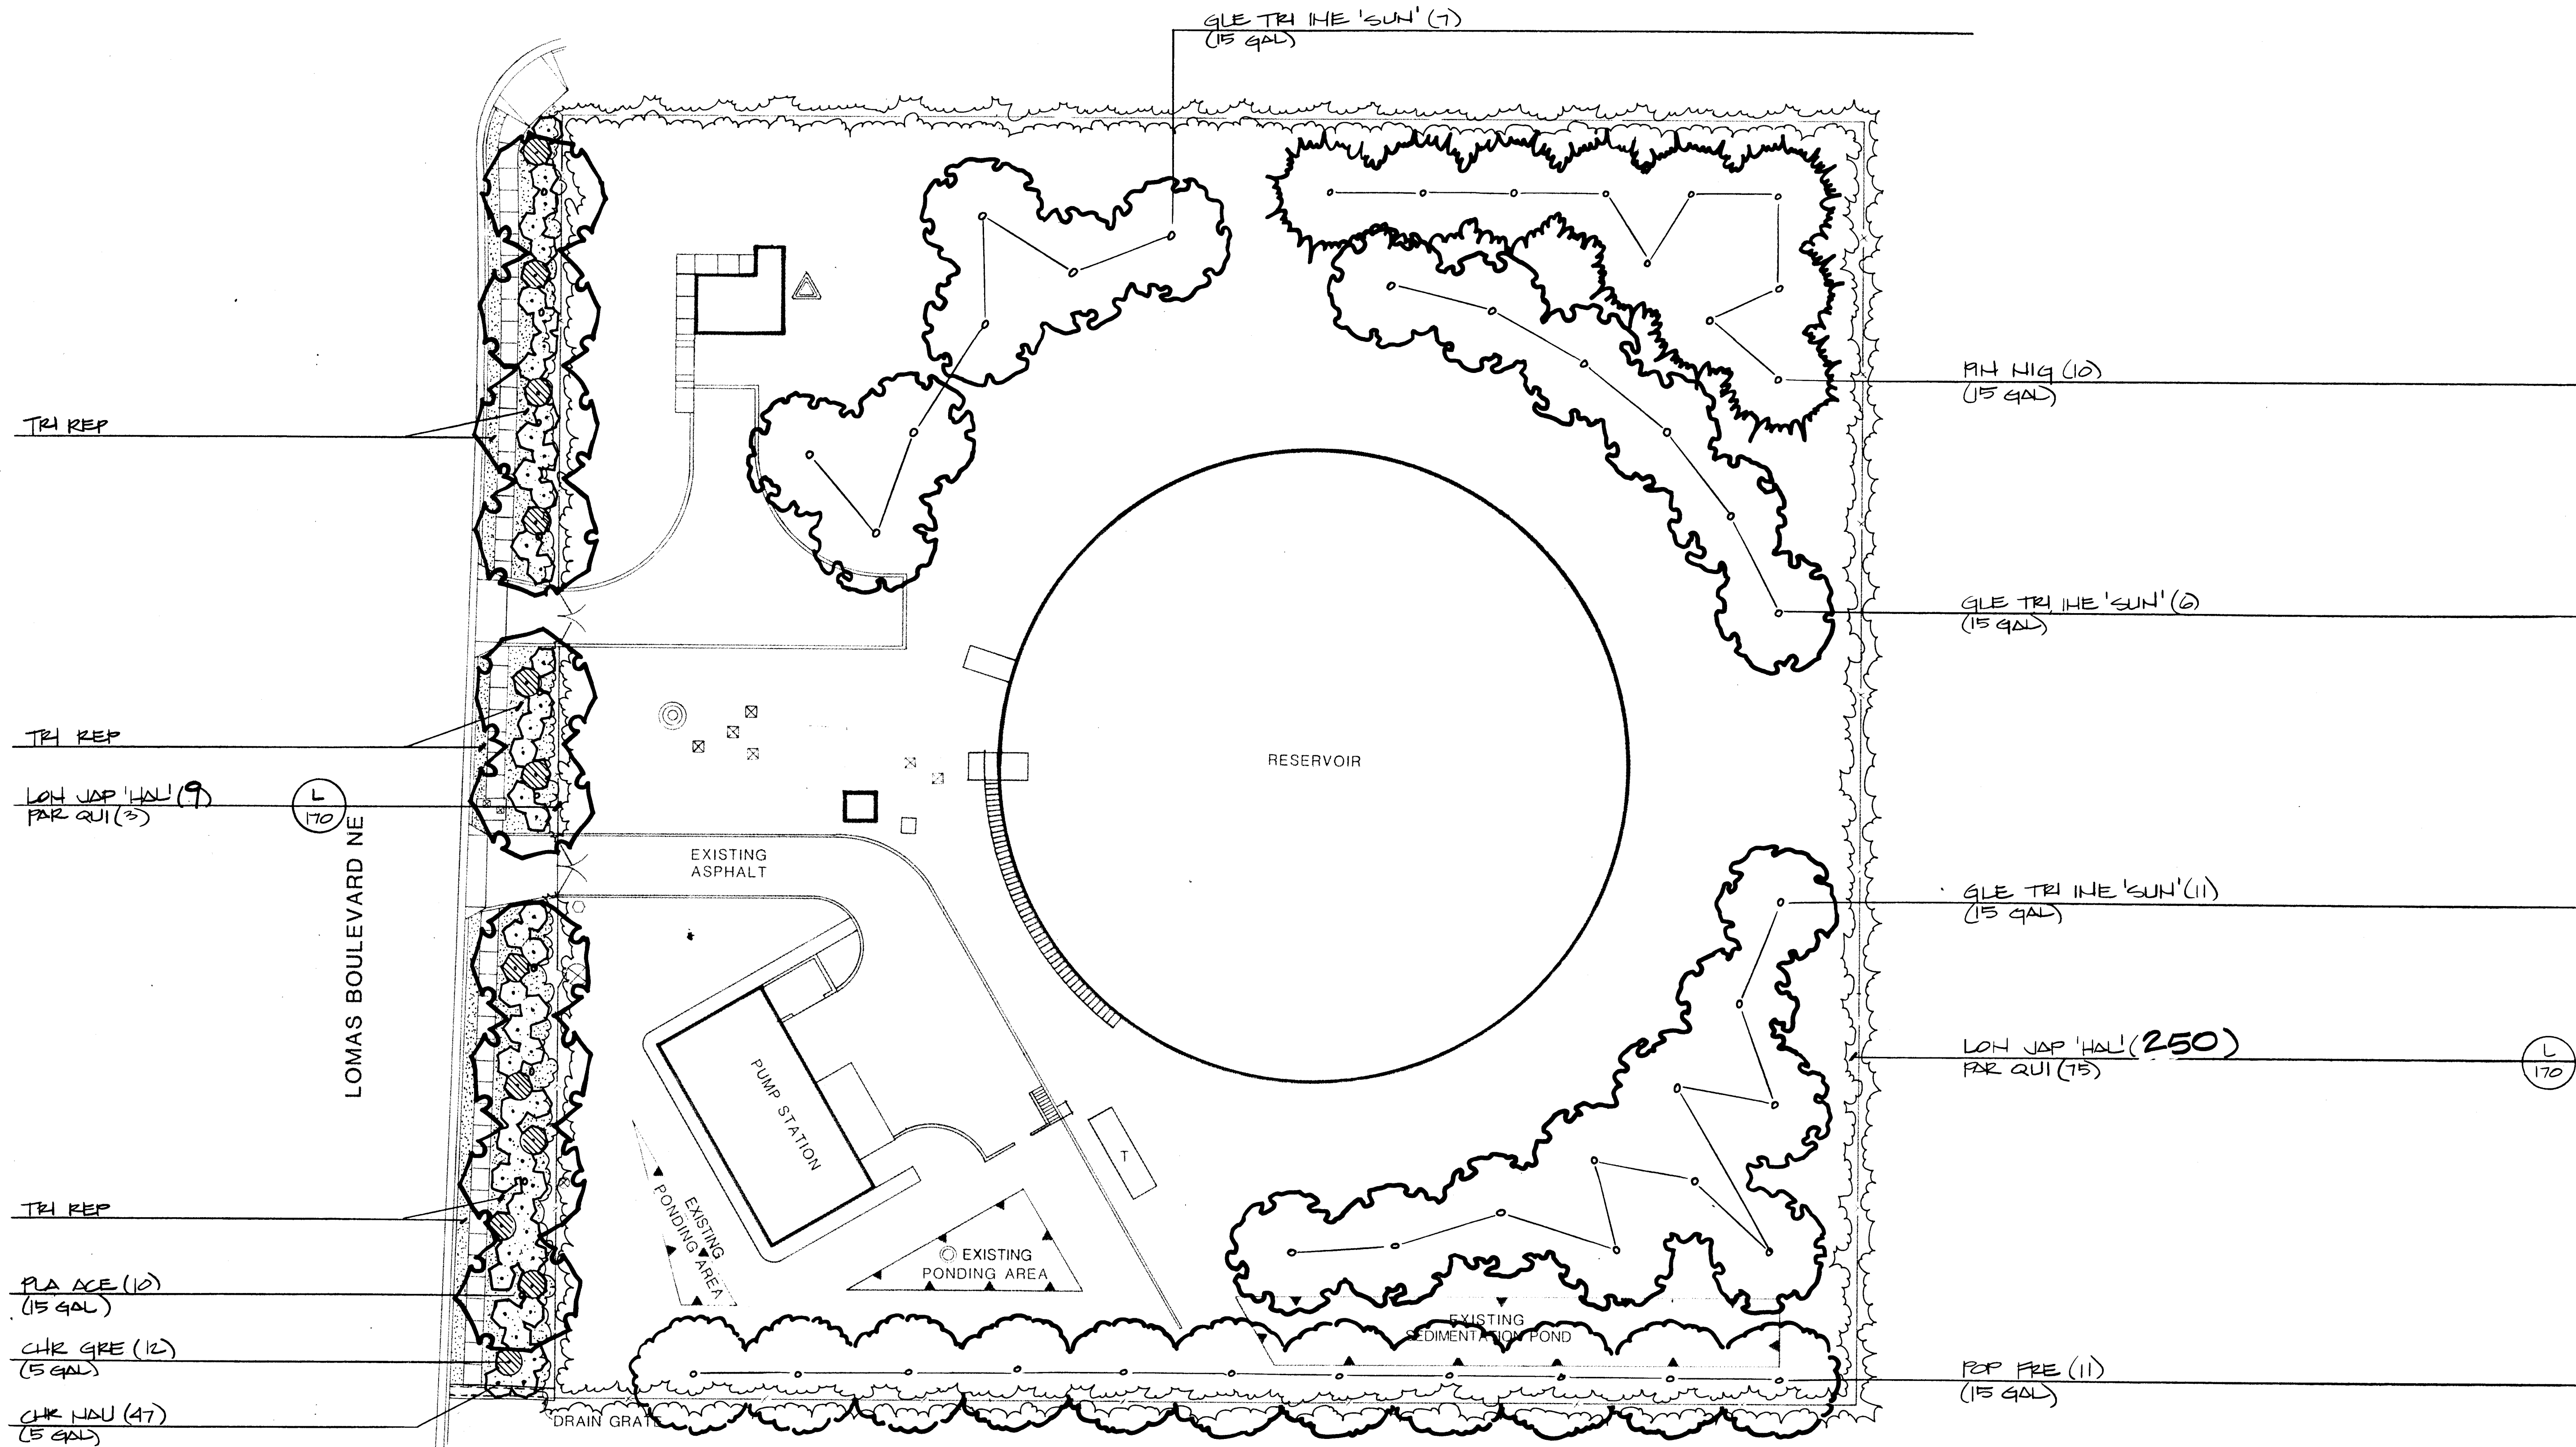


SCALE 1"=20'-0"

0 10 20 40

26 309710086

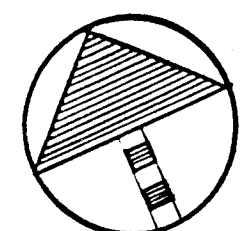

MORROW & COMPANY
LANDSCAPE ARCHITECTS
210 La Veta Drive NE
Albuquerque, New Mexico 87108
505-268-2266

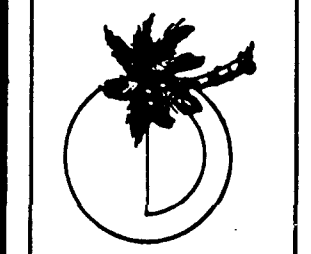



NOVEMBER
1986

SANDIA MANOR RESERVOIR & PUMP STATION
AS BUILT
15000 LOMAS BOULEVARD NE
PLANTING PLAN


LANDSCAPING IMPROVEMENTS FOR
WATER SYSTEM FACILITY SITES
WATER SYSTEMS DIVISION
CITY OF ALBUQUERQUE
ALBUQUERQUE, NEW MEXICO

SHEET
117
OF
172

SAN JOSE
COMMUNITY
CENTER

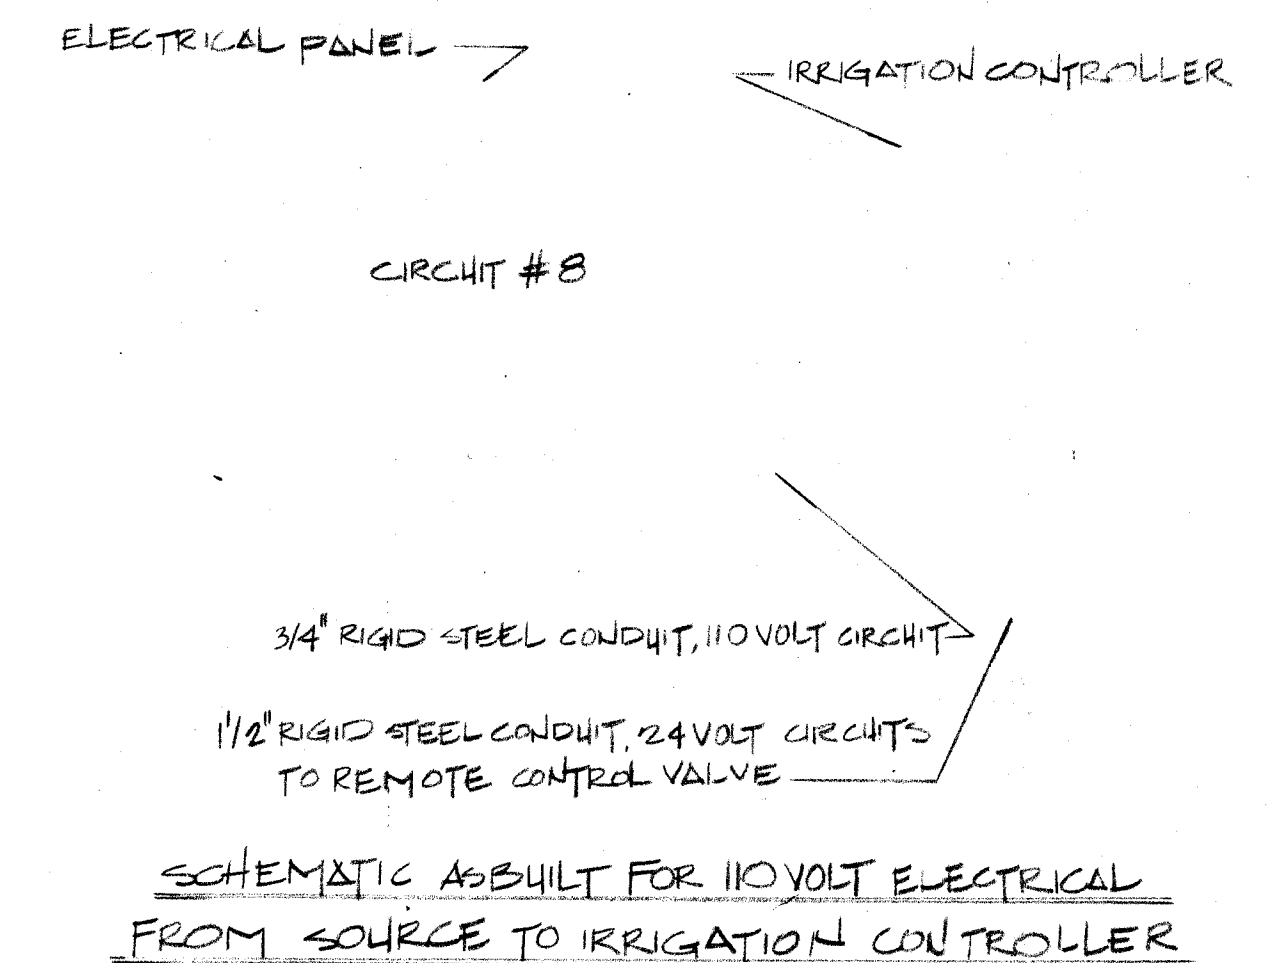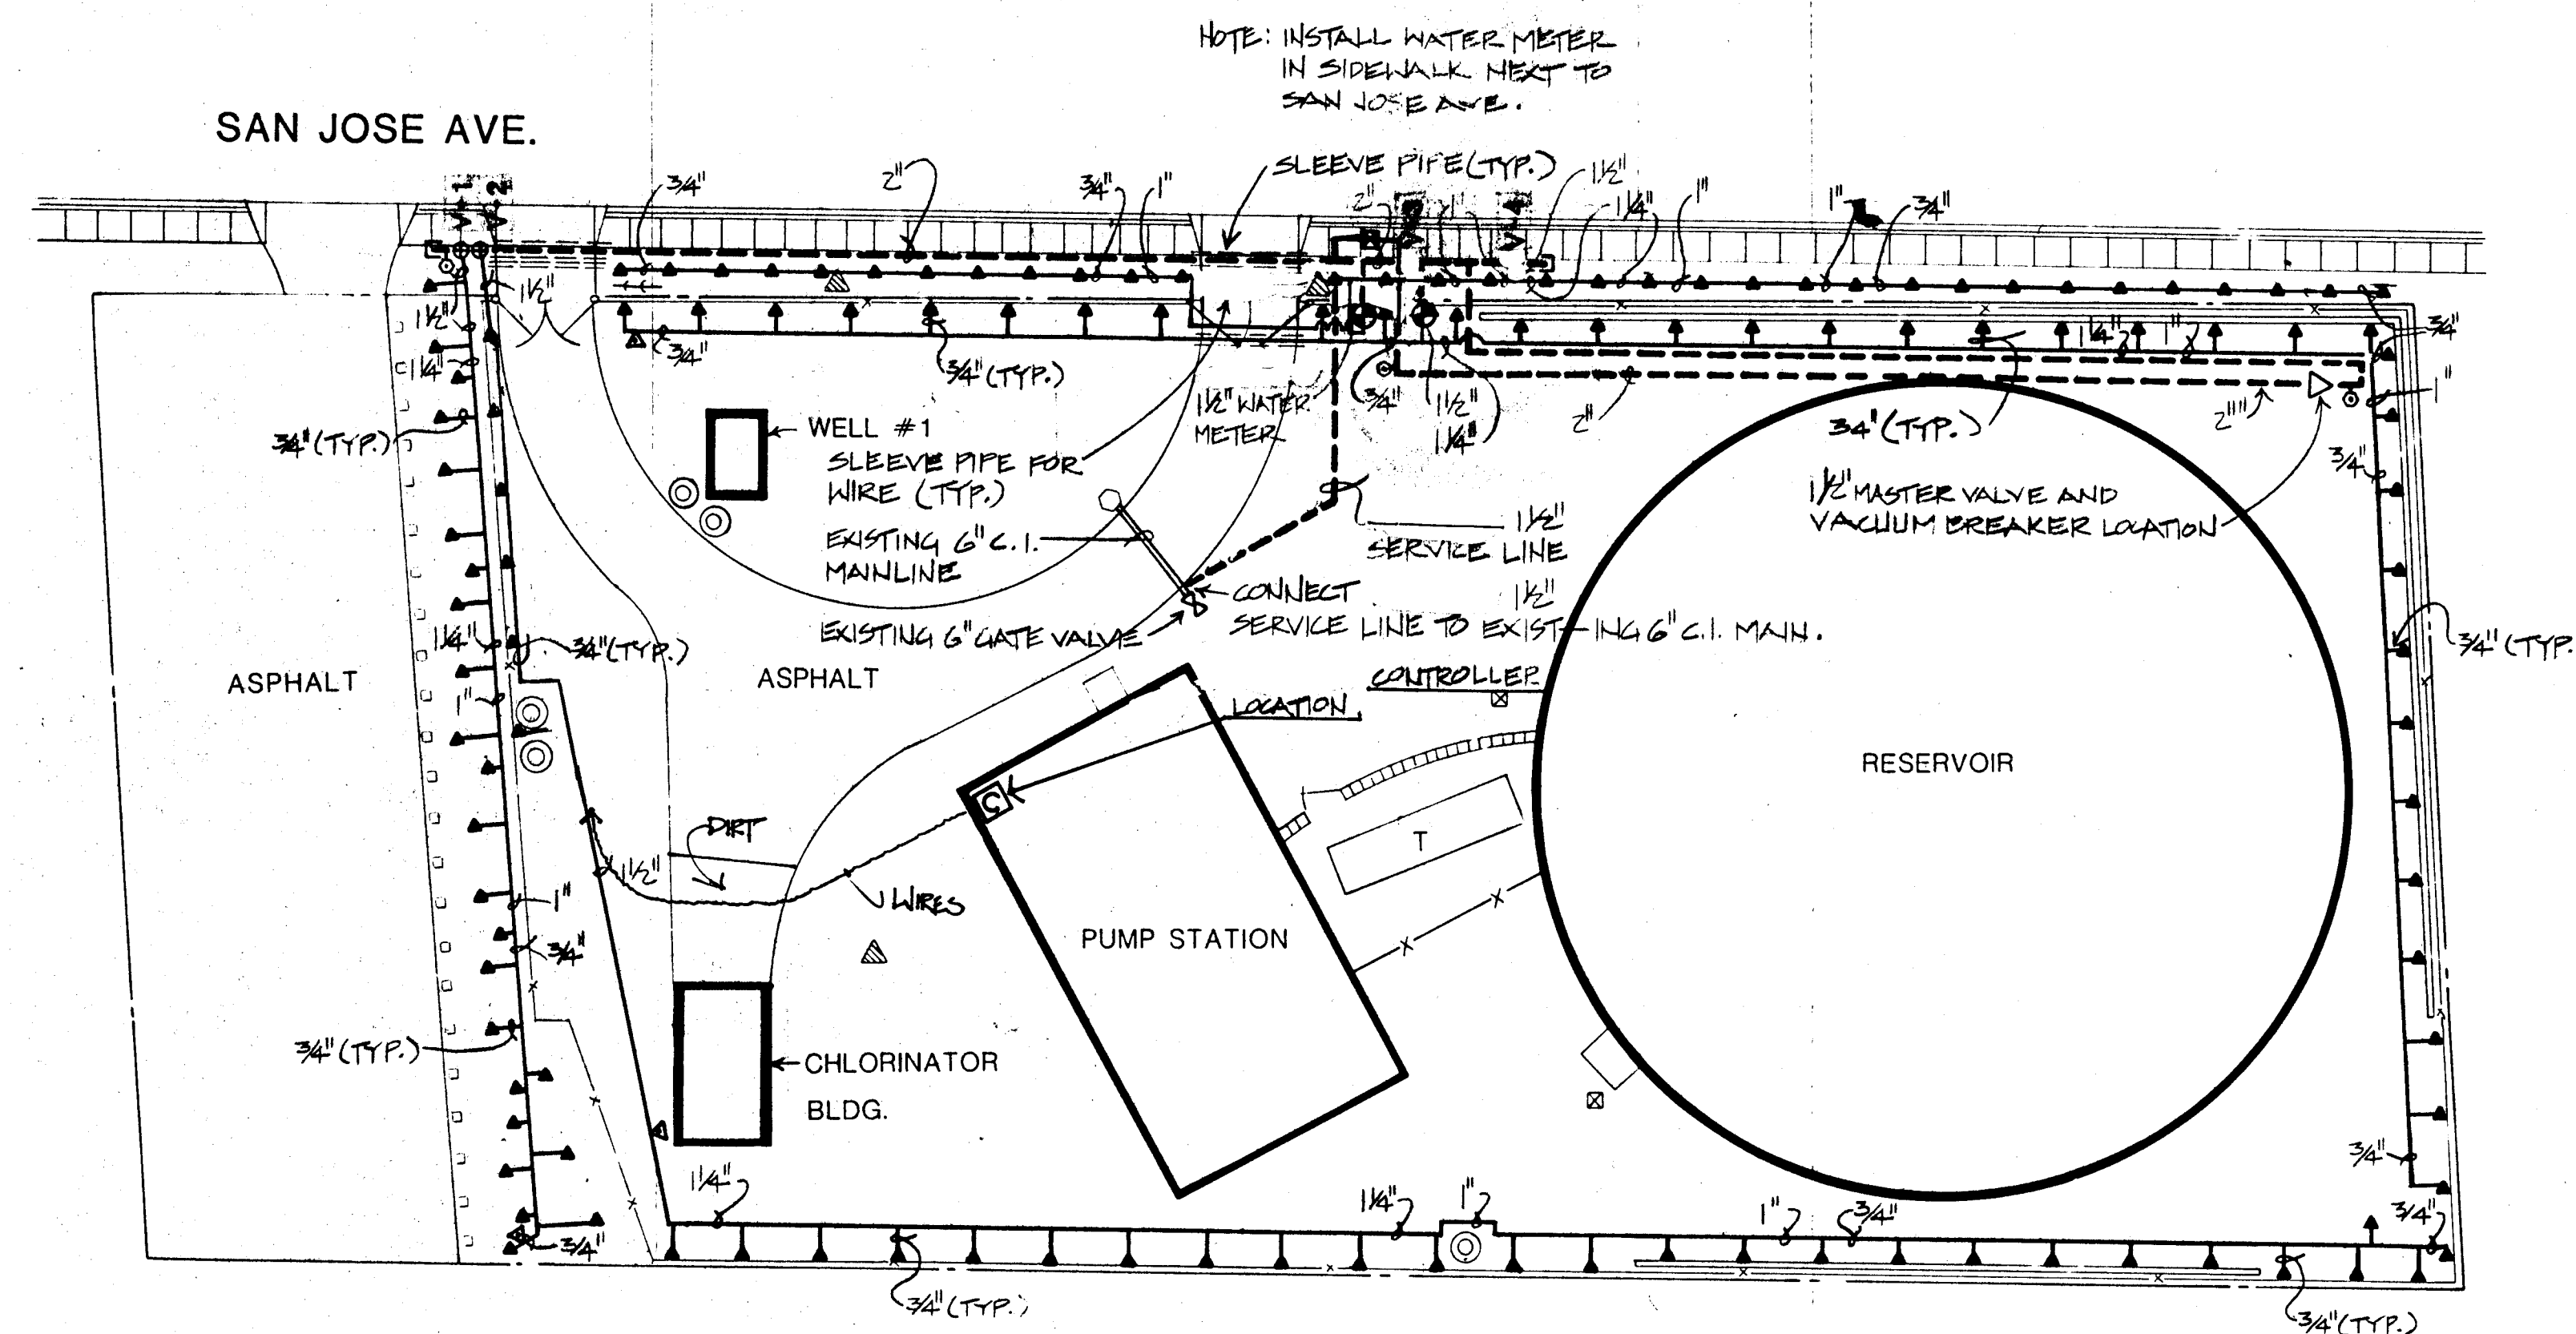

SCALE 1"=20'-0"

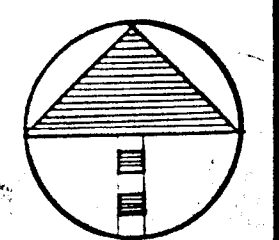

26 30974 0186

MORROW & COMPANY
LANDSCAPE ARCHITECTS
210 La Veta Drive NE
Albuquerque, New Mexico 87108
505-268-2266

NOVEMBER
1986


SAN JOSE WELL #1, RESERVOIR & PUMP STATION
500 SAN JOSE AVENUE SE

IRRIGATION PLAN


AS BUILT

LANDSCAPING IMPROVEMENTS FOR
WATER SYSTEM FACILITY SITES
WATER SYSTEMS DIVISION
CITY OF ALBUQUERQUE
ALBUQUERQUE, NEW MEXICO


SHEET
172

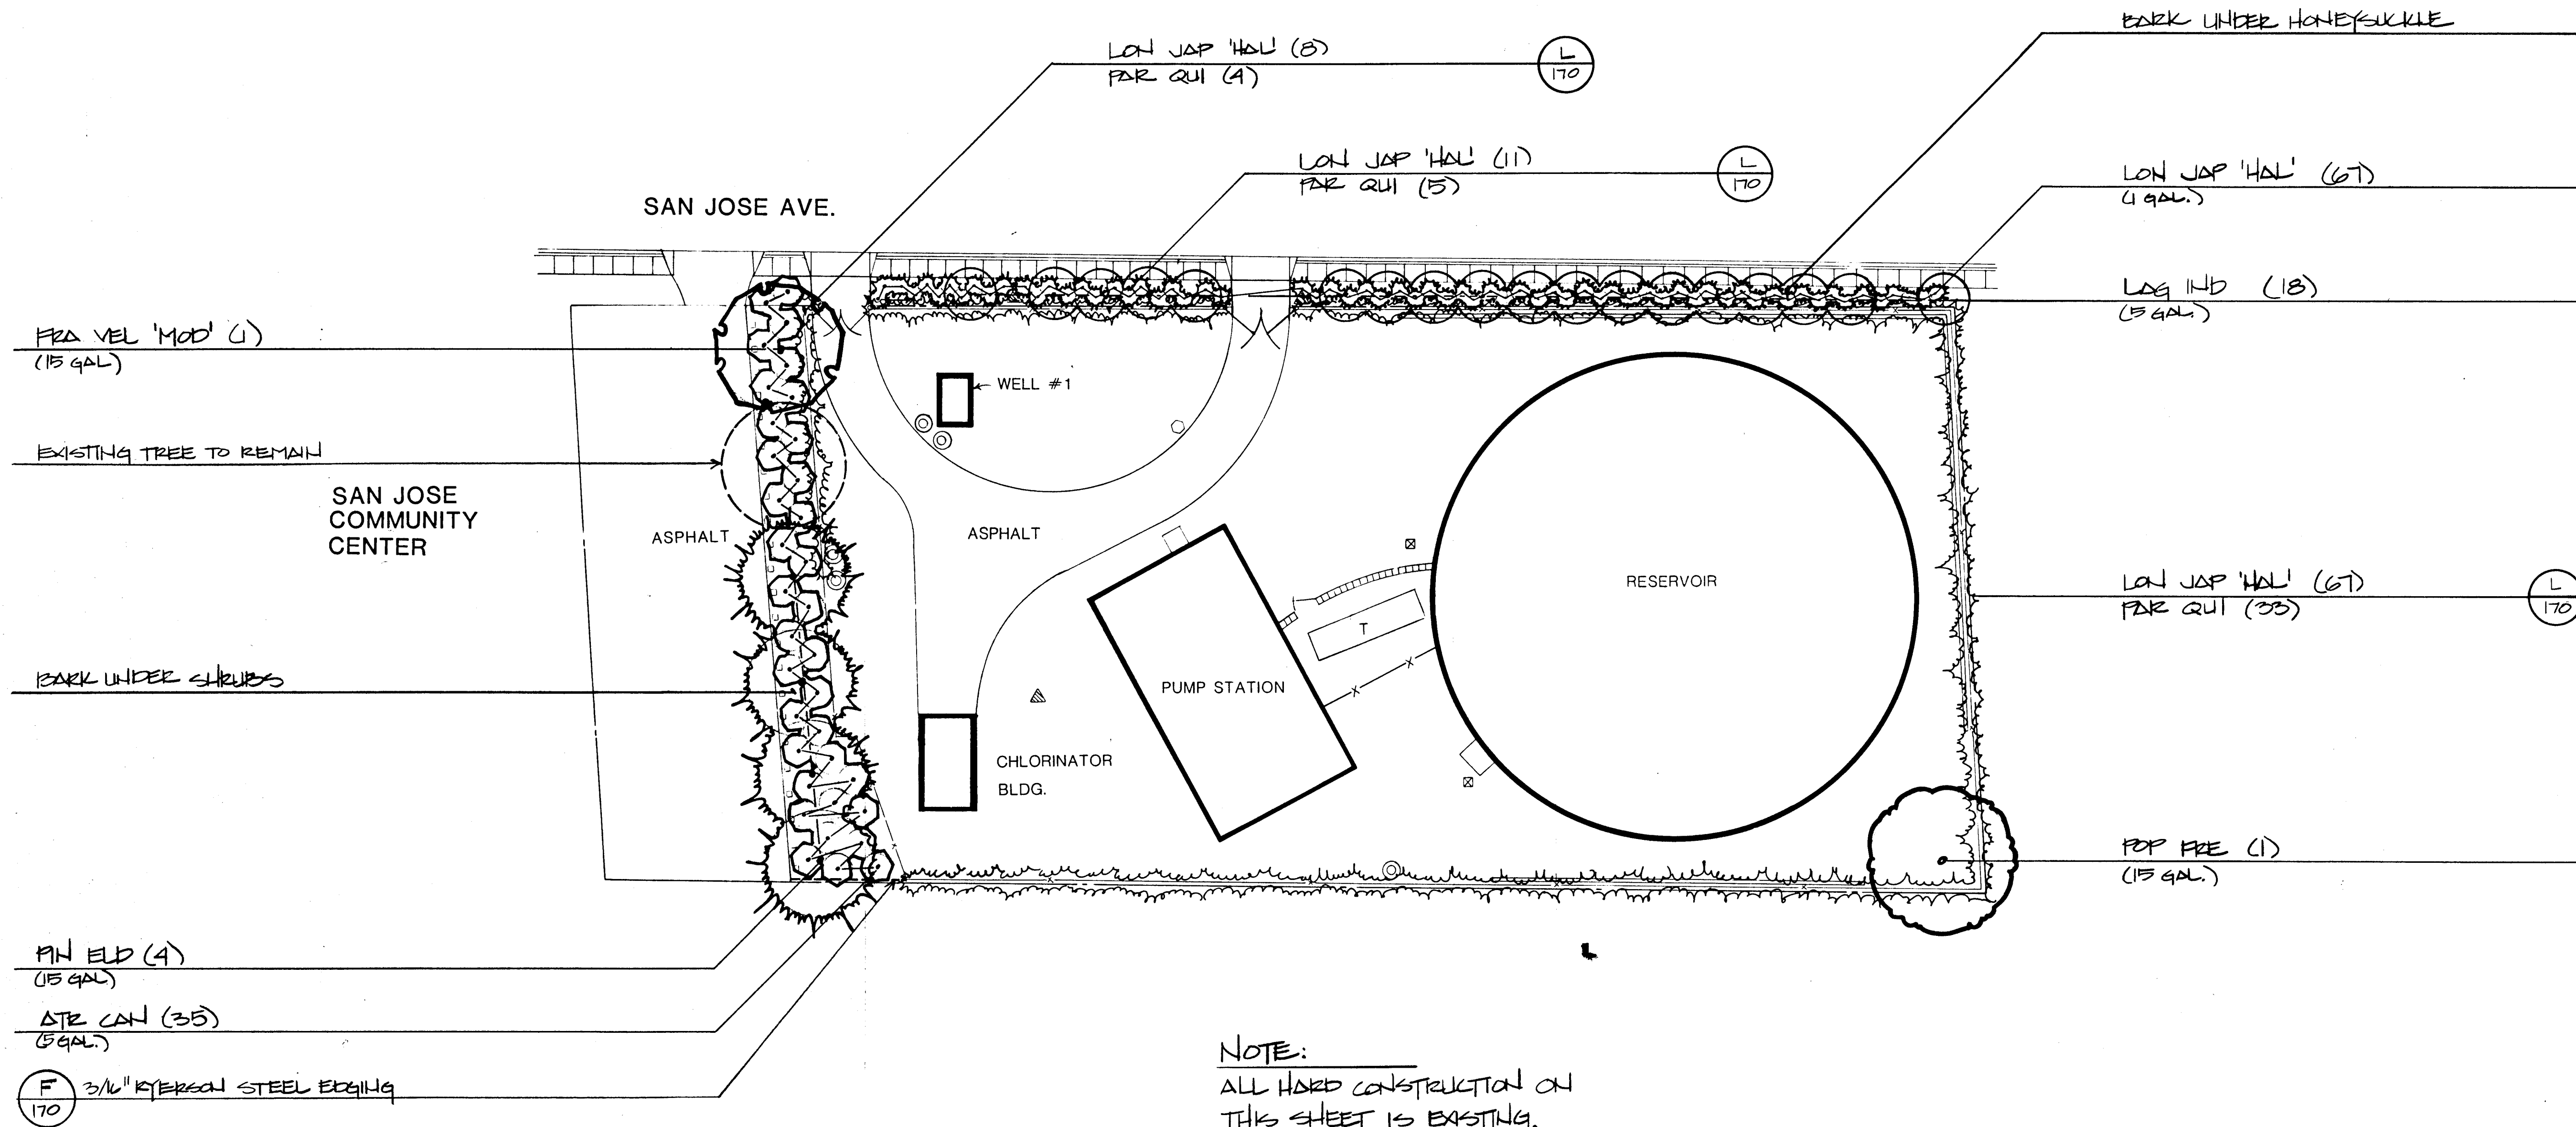


SCALE 1"=20'-0"

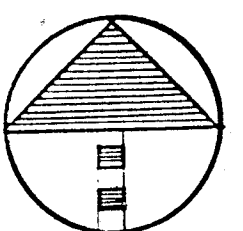

26 309710286

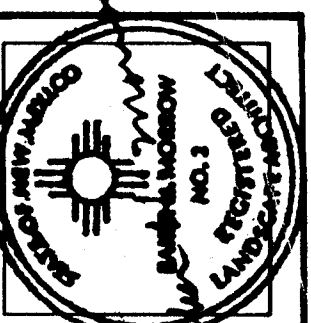

MORROW & COMPANY
LANDSCAPE ARCHITECTS
210 La Veta Drive NE
Albuquerque, New Mexico 87108
505-268-2266

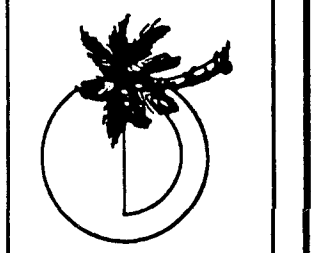


NOVEMBER
1986


AS BUILT
SAN JOSE WELL #1, RESERVOIR & PUMP STATION
500 SAN JOSE AVENUE SE
PLANTING PLAN

LANDSCAPING IMPROVEMENTS FOR
WATER SYSTEM FACILITY SITES
WATER SYSTEMS DIVISION
CITY OF ALBUQUERQUE
ALBUQUERQUE, NEW MEXICO

SHEET
11
172

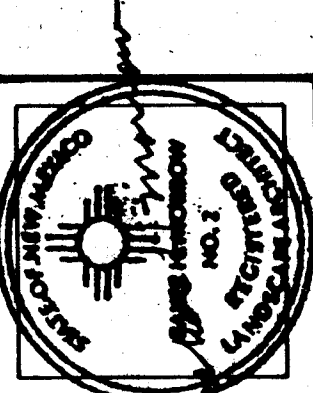

MORROW & COMPANY
LANDSCAPE ARCHITECTS
210 La Veta Drive NE
Albuquerque, New Mexico 87108
505-268-2266

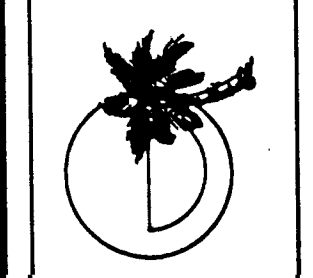


NOVEMBER
1986

SANTA BARBARA WELL #1 AND RESERVOIR
3301 CLAREMONT AVE. NE
GRADING PLAN
AS BUILT

LANDSCAPING IMPROVEMENTS FOR
WATER SYSTEM FACILITY SITES
WATER SYSTEMS DIVISION
CITY OF ALBUQUERQUE
ALBUQUERQUE, NEW MEXICO


SHEET
12
11
10

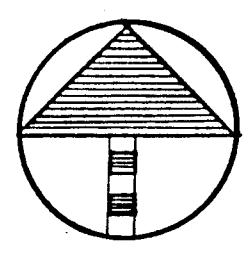

SCALE 1"=20'-0"
0 10 20 40


26 309710386



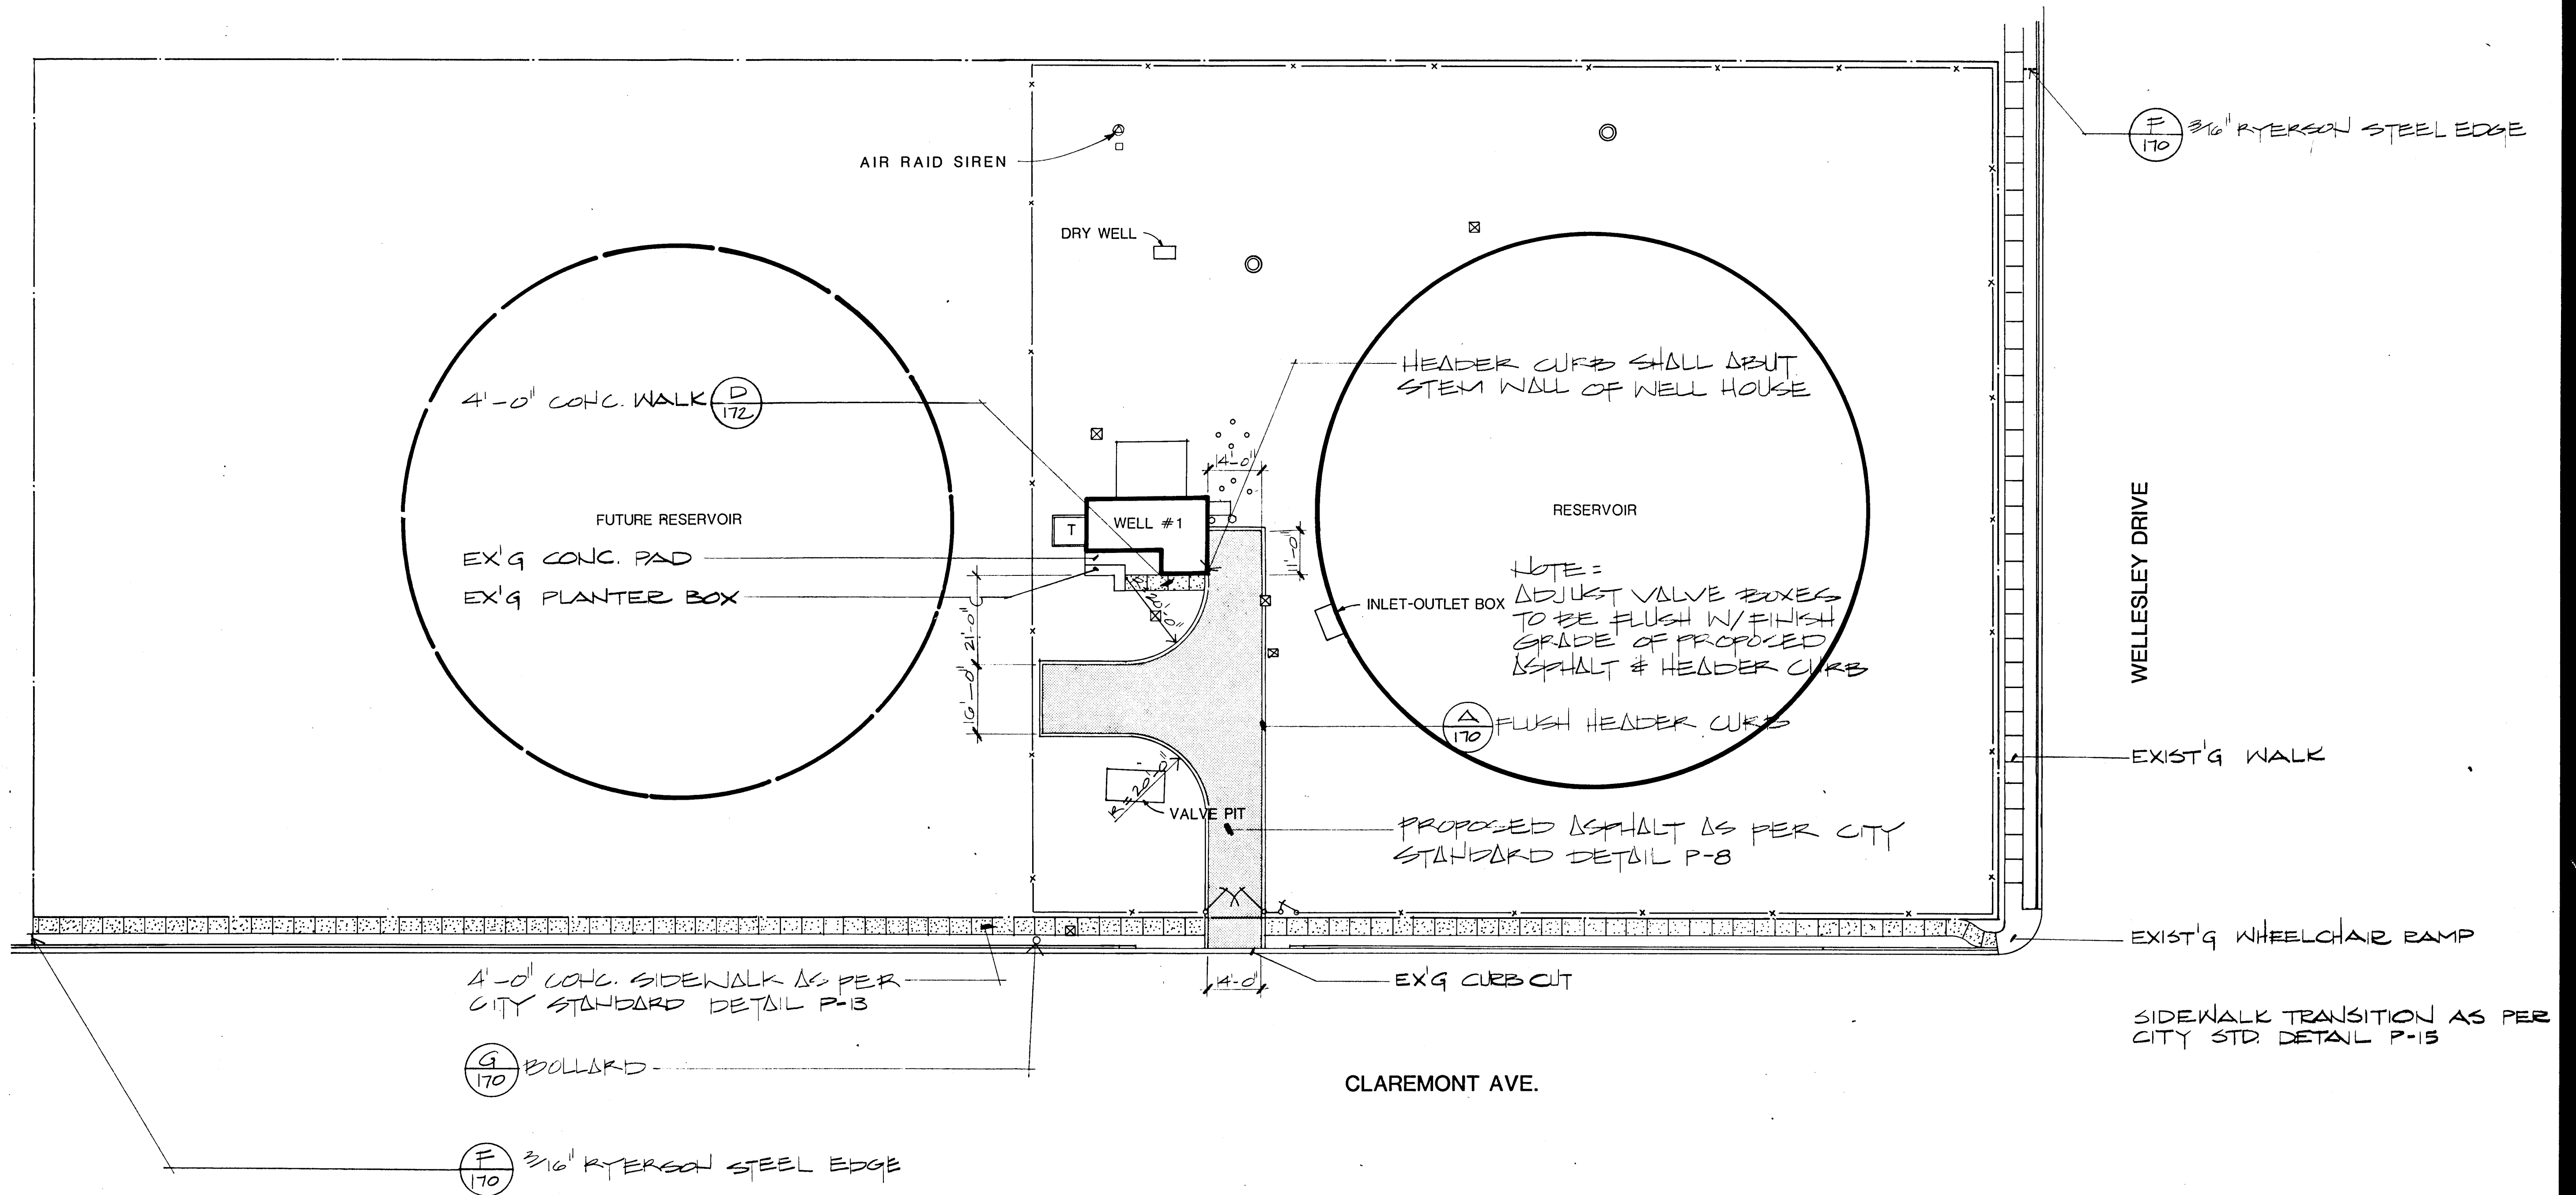


SCALE 1"=20'-0"

0 10 20 40

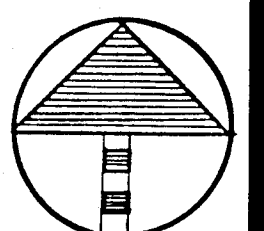

26 309710486

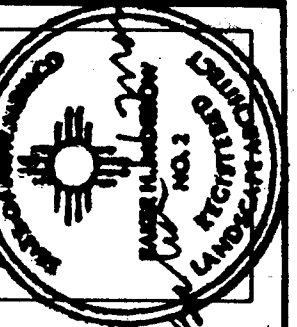

MORROW & COMPANY
LANDSCAPE ARCHITECTS
210 La Veta Drive NE
Albuquerque, New Mexico 87108
505-268-2266





NOVEMBER
1986

SANTA BARBARA WELL #1 AND RESERVOIR
3301 CLAREMONT AVE. NE
CONSTRUCTION PLAN

AS BUILT

LANDSCAPING IMPROVEMENTS FOR
WATER SYSTEM FACILITY SITES
WATER SYSTEMS DIVISION
CITY OF ALBUQUERQUE
ALBUQUERQUE, NEW MEXICO

SHEET
123
107
172

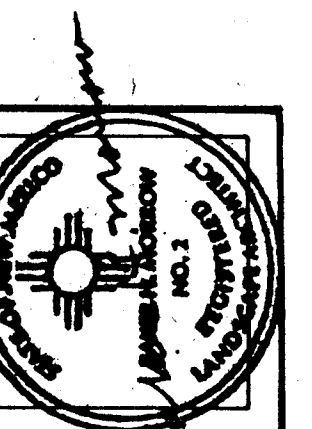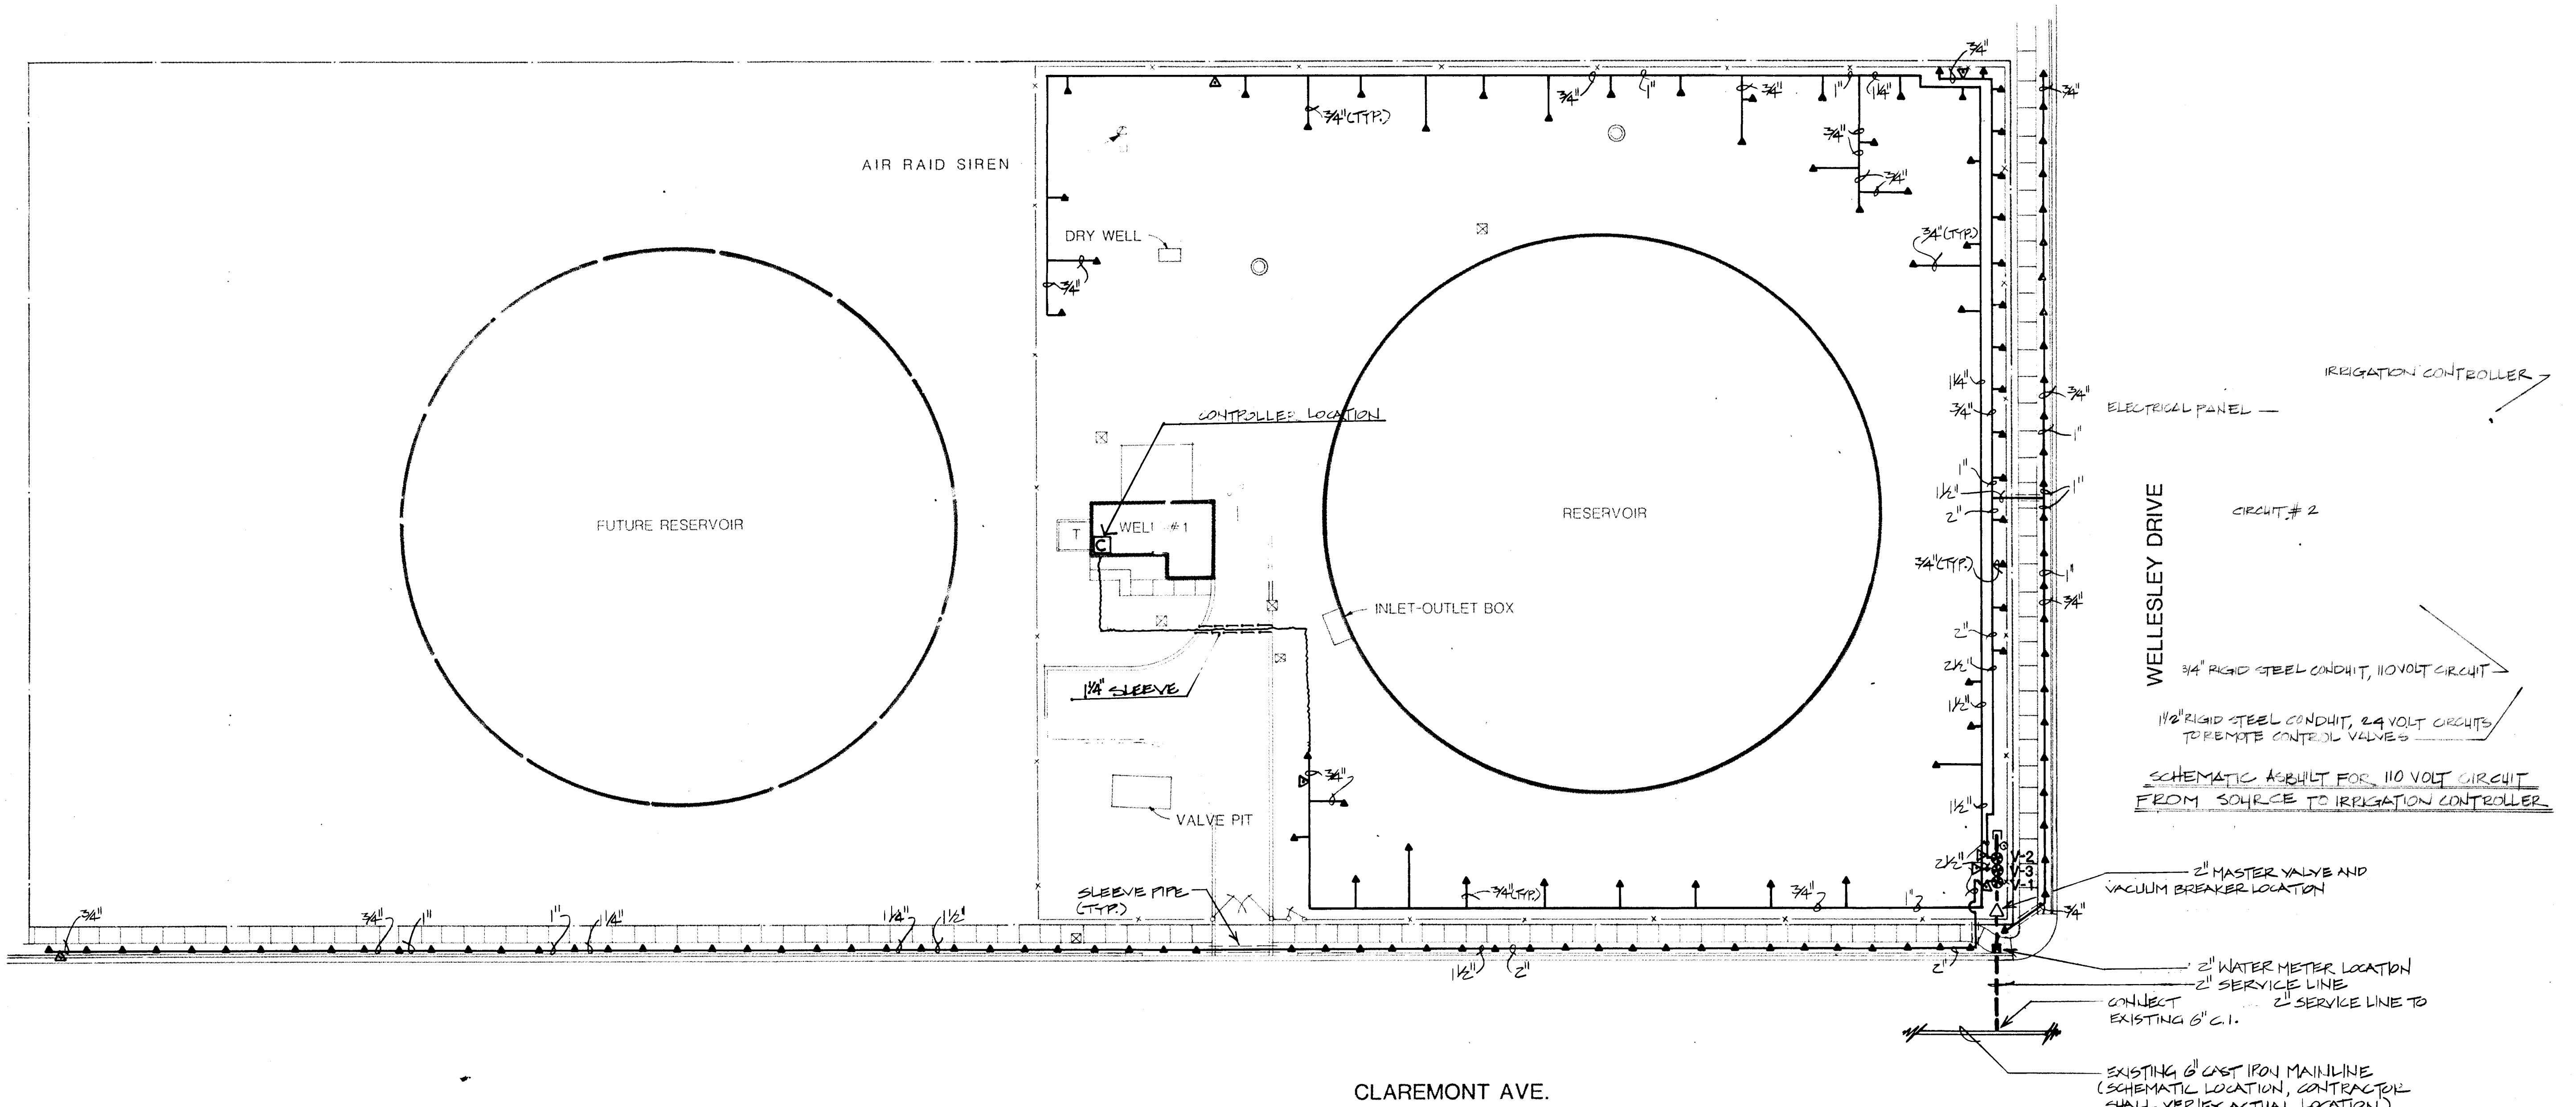

MORROW & COMPANY
LANDSCAPE ARCHITECTS
210 La Veta Drive NE
Albuquerque, New Mexico 87108
505-268-2266




NOVEMBER
1986

SANTA BARBARA WELL #1 AND RESERVOIR
3301 CLAREMONT AVE. NE
AS BUILT
IRRIGATION PLAN


LANDSCAPING IMPROVEMENTS FOR
WATER SYSTEM FACILITY SITES
WATER SYSTEMS DIVISION
CITY OF ALBUQUERQUE
ALBUQUERQUE, NEW MEXICO

SHEET
120
12


SCALE 1" = 20'-0"
0 10 20 40

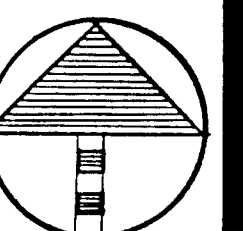

2.6 30.9710586

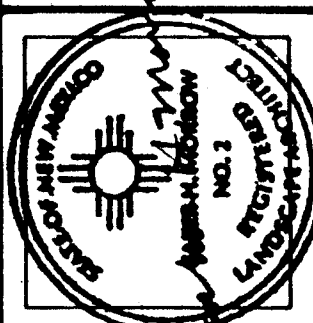

MORROW & COMPANY
LANDSCAPE ARCHITECTS
210 La Veta Drive NE
Albuquerque, New Mexico 87108
505-268-2266

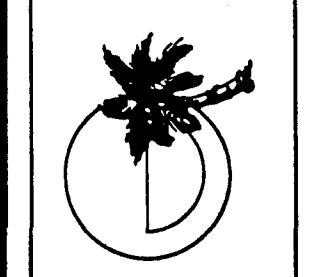


NOVEMBER
1986


SANTA BARBARA WELL #1 AND RESERVOIR
3301 CLAREMONT AVE. NE
PLANTING PLAN
AS BUILT

LANDSCAPING IMPROVEMENTS FOR
WATER SYSTEM FACILITY SITES
CITY OF ALBUQUERQUE
ALBUQUERQUE, NEW MEXICO


SHEET
127
128
129
130
131
132

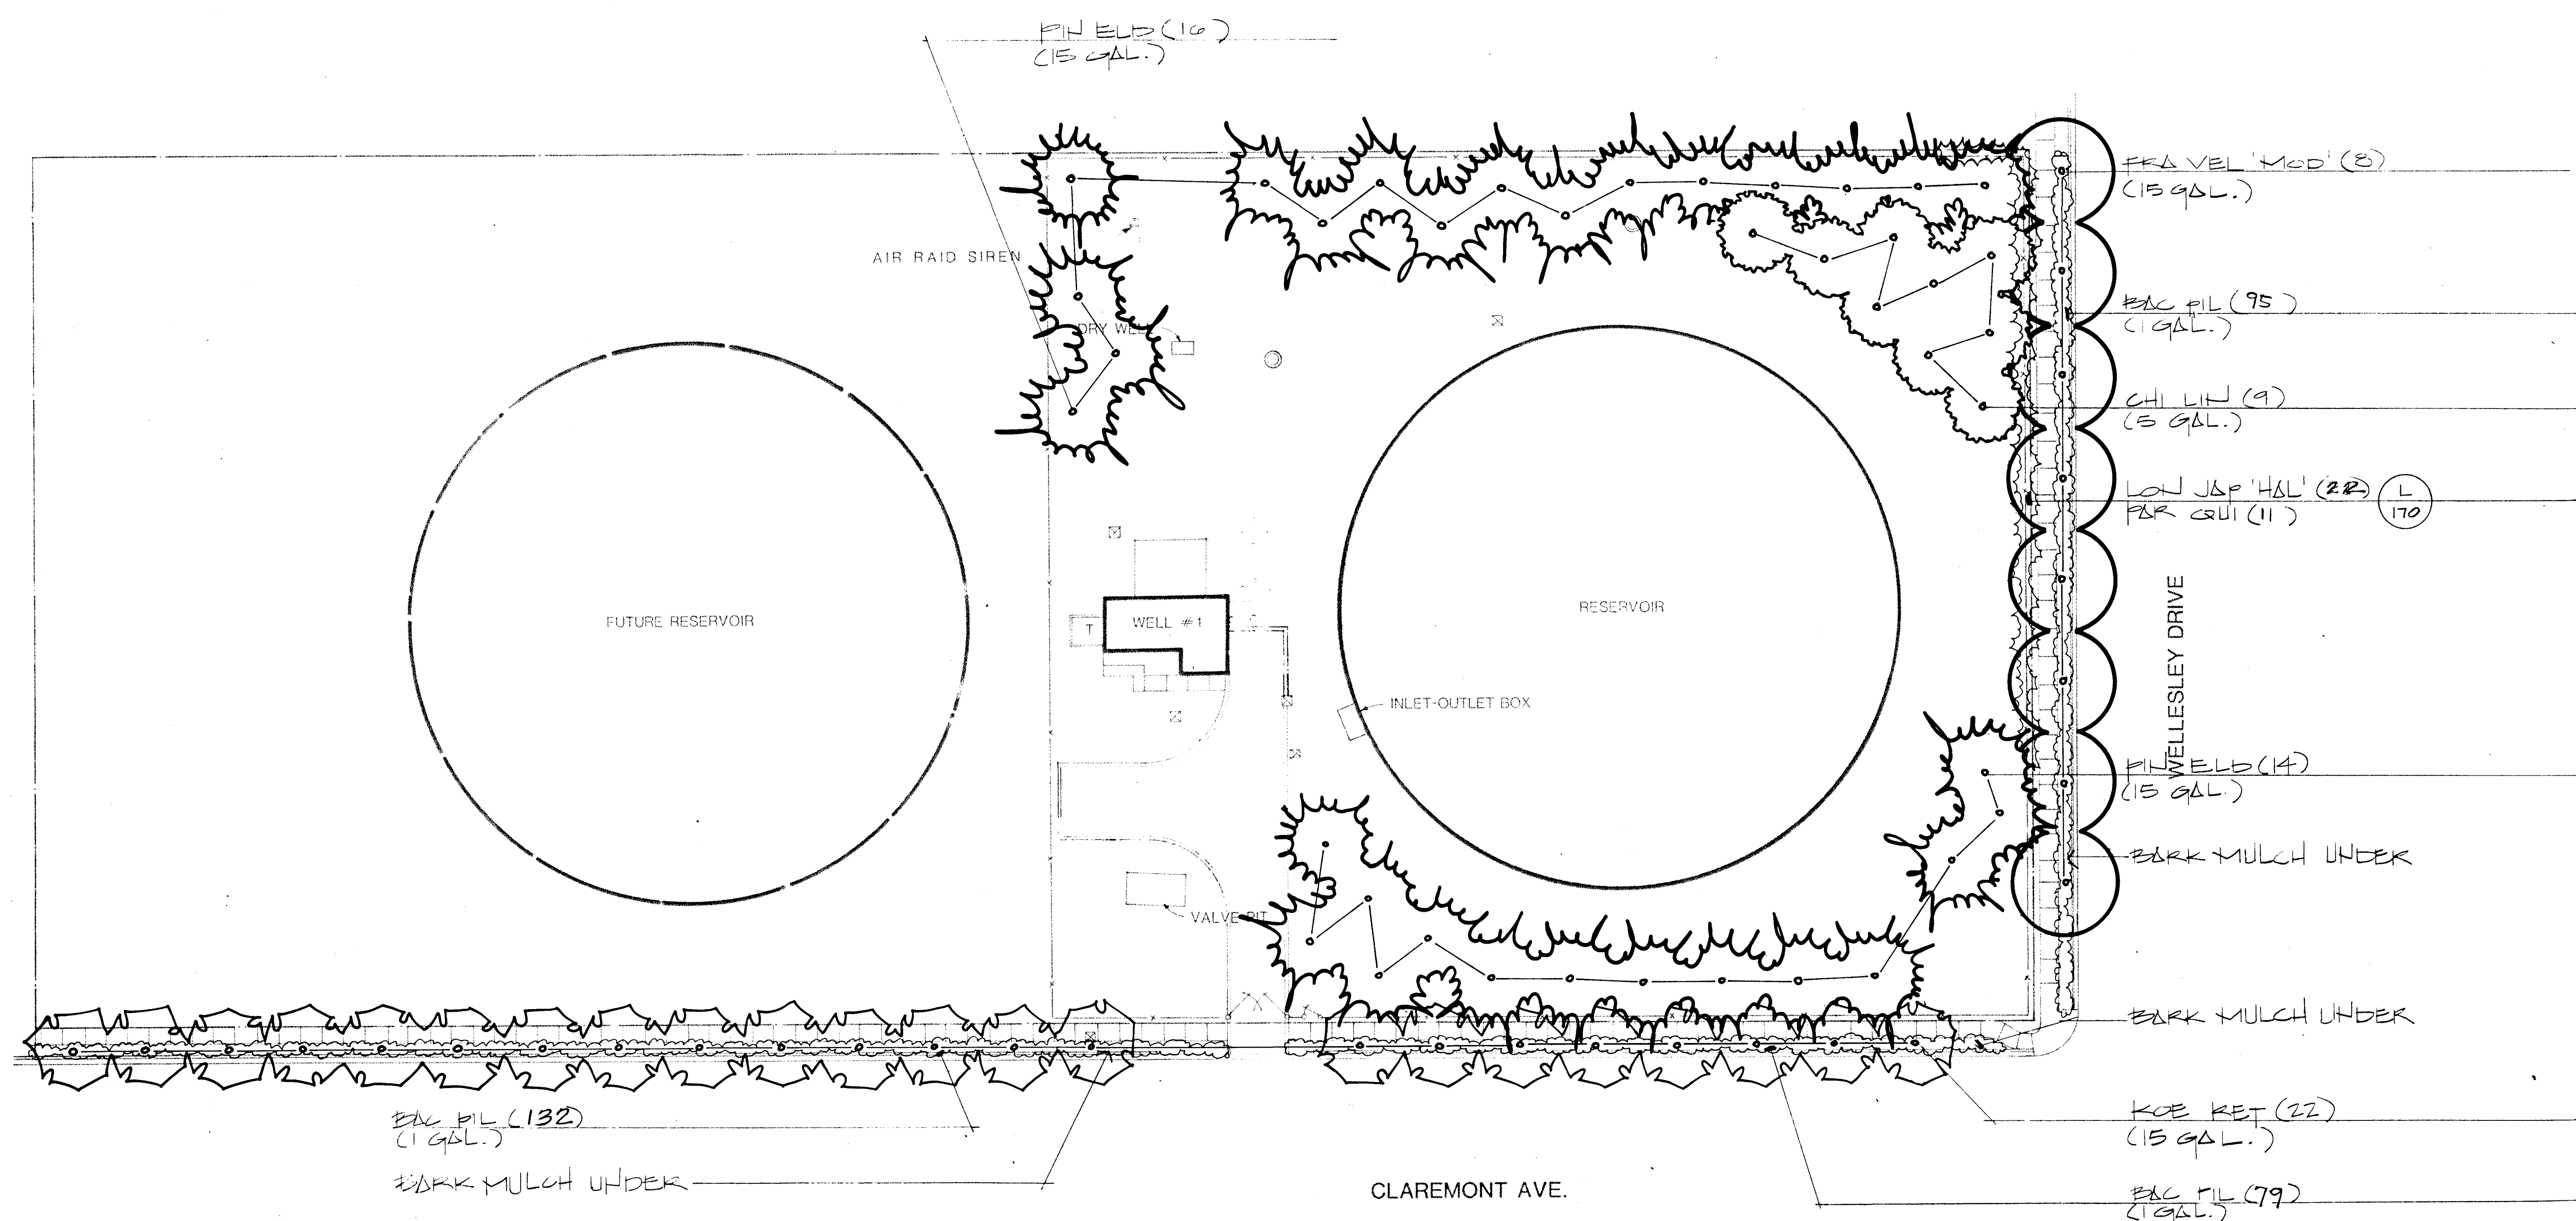

SCALE 1"=20'-0"
0 10 20 40

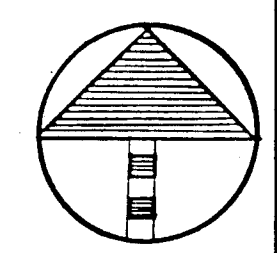


26.309710686

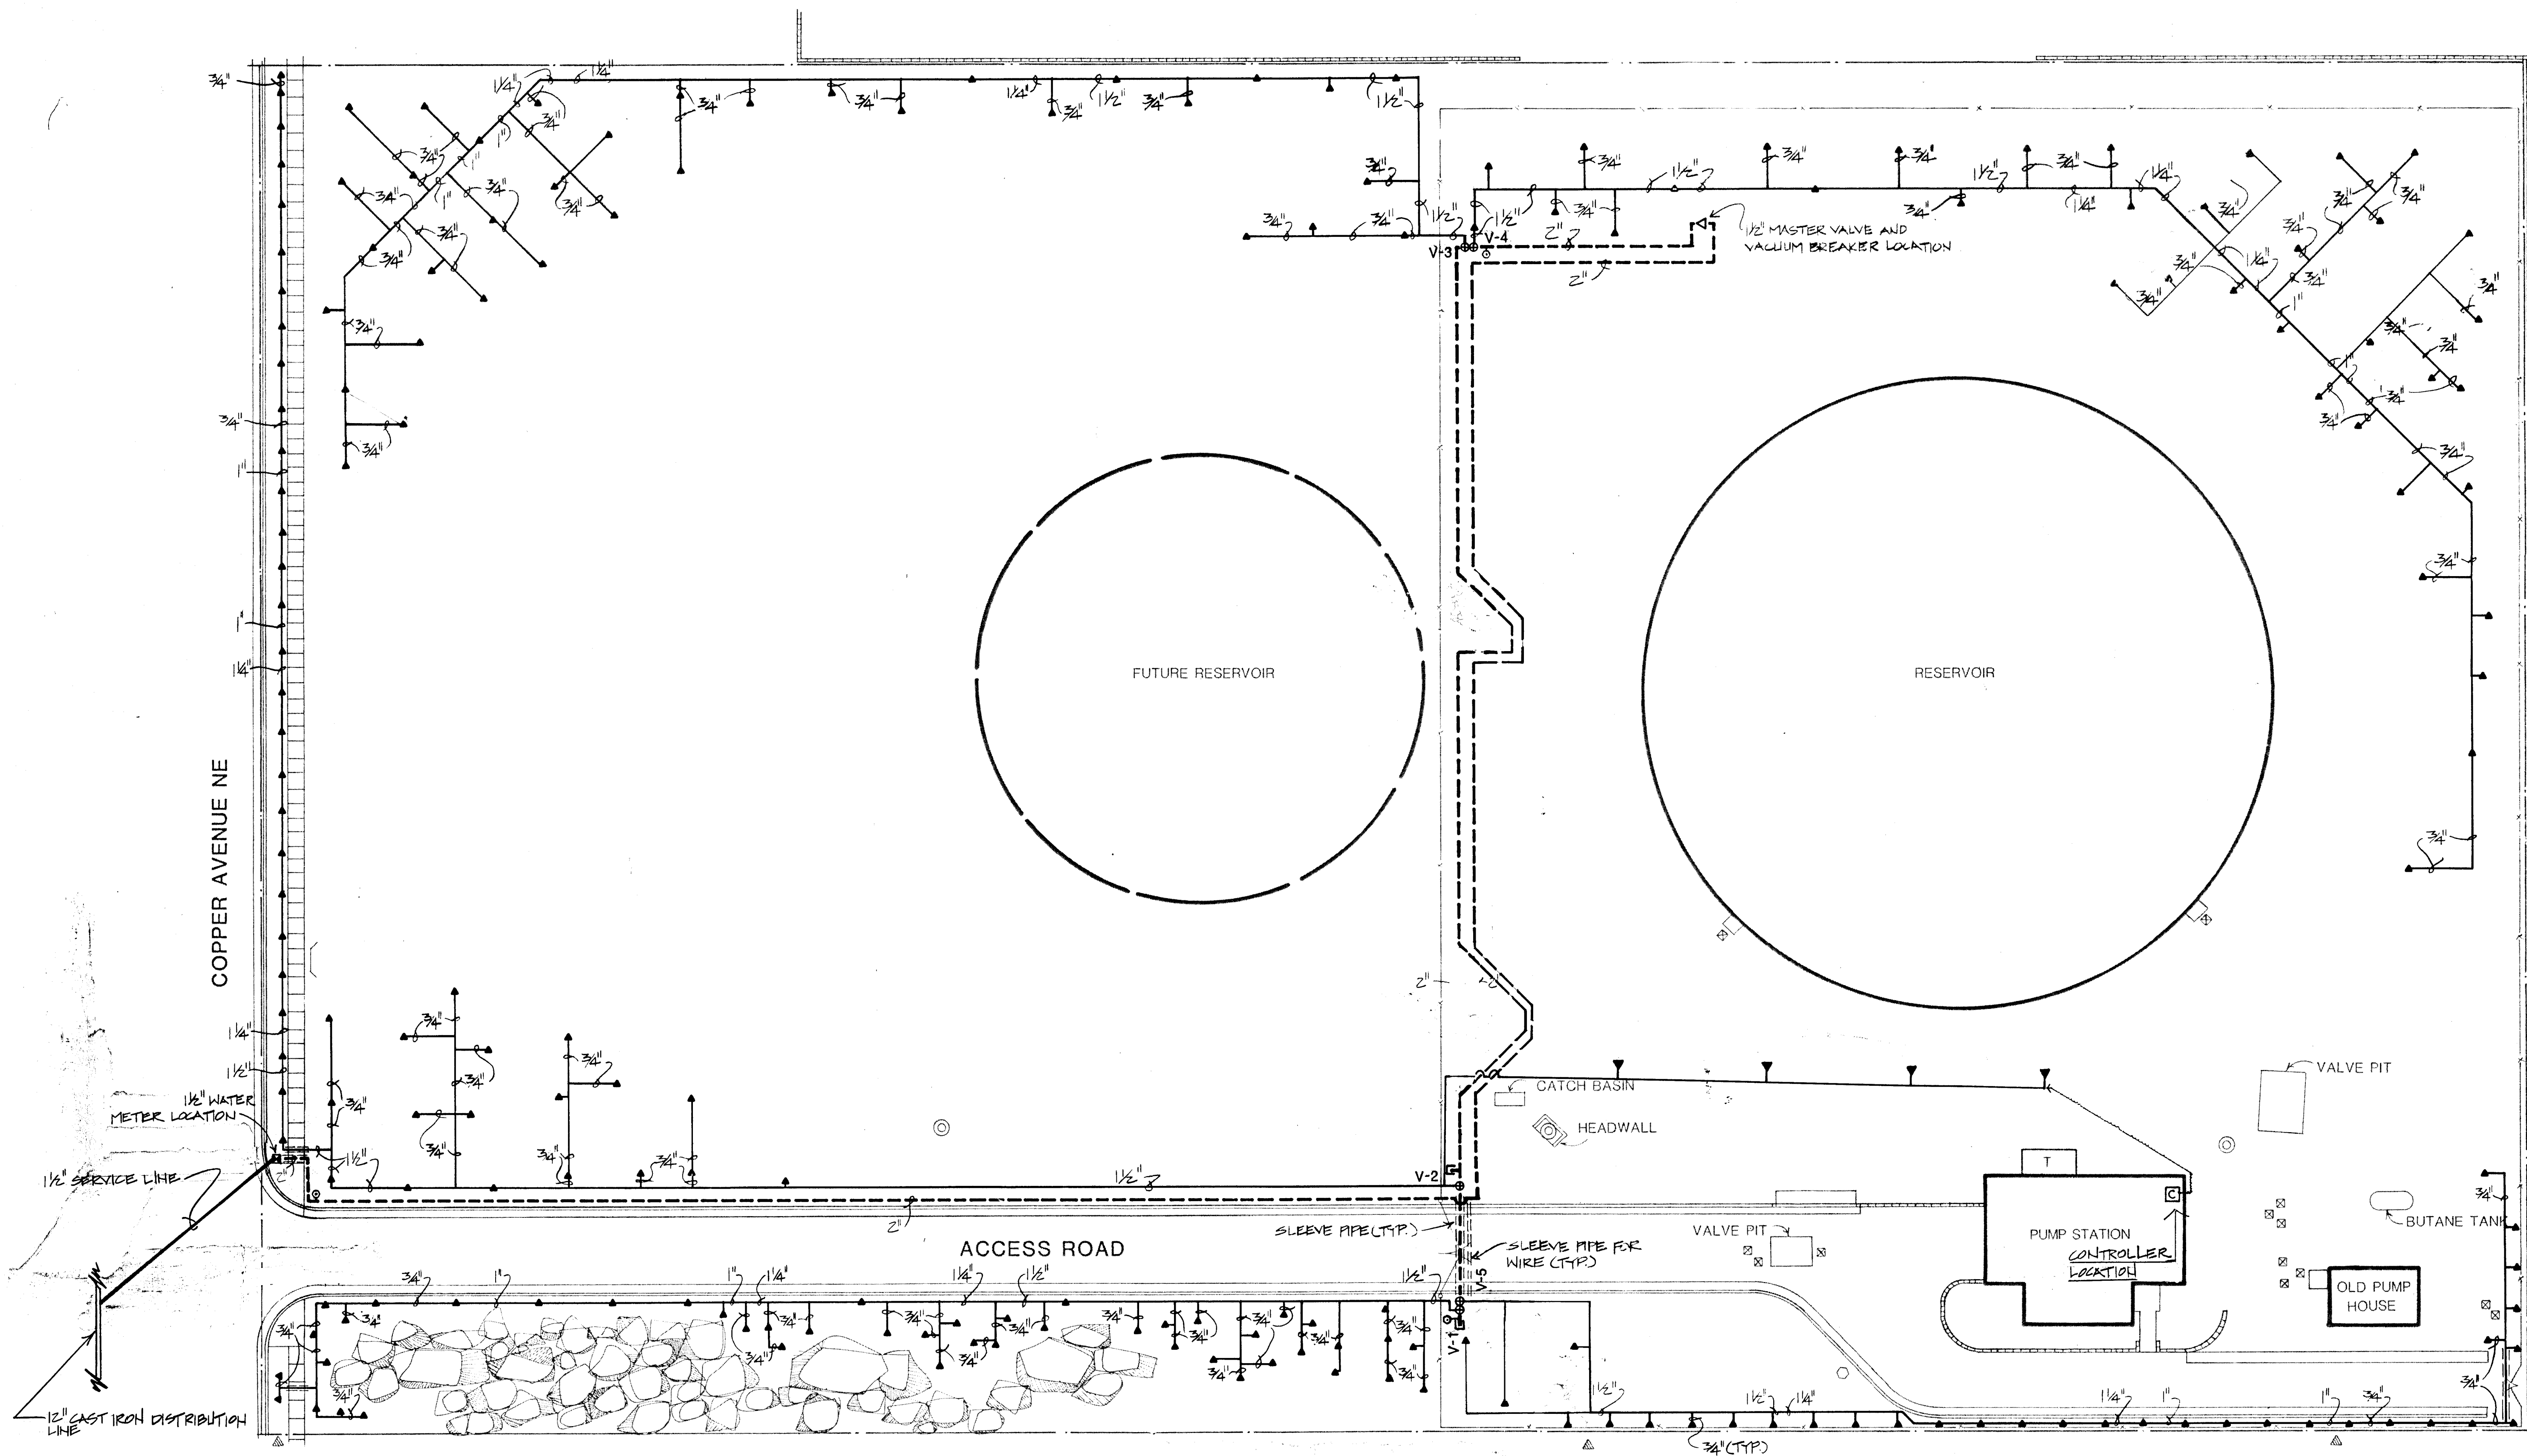


SCHEMATIC ASBUILT FOR 110VOLT ELECTRICAL
FROM SOURCE TO IRRIGATION CONTROLLER

SCALE 1"=20'-0"
0 10 20 40

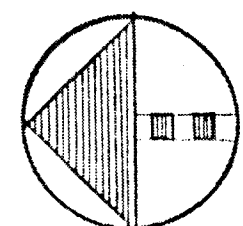

26 309710786

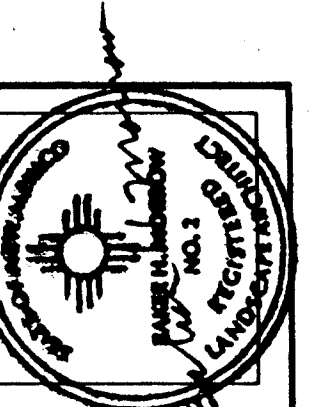

MORROW & COMPANY
LANDSCAPE ARCHITECTS
210 La Veta Drive NE
Albuquerque, New Mexico 87108
505-268-2266




NOVEMBER
1986

AS BUILT
SUPPER ROCK RESERVOIR & PUMP STATION
14529 MEL SMITH ROAD NE
IRRIGATION PLAN

LANDSCAPING IMPROVEMENTS FOR
WATER SYSTEM FACILITY SITES
WATER SYSTEMS DIVISION
CITY OF ALBUQUERQUE
ALBUQUERQUE, NEW MEXICO

SHEET
120
OF
172

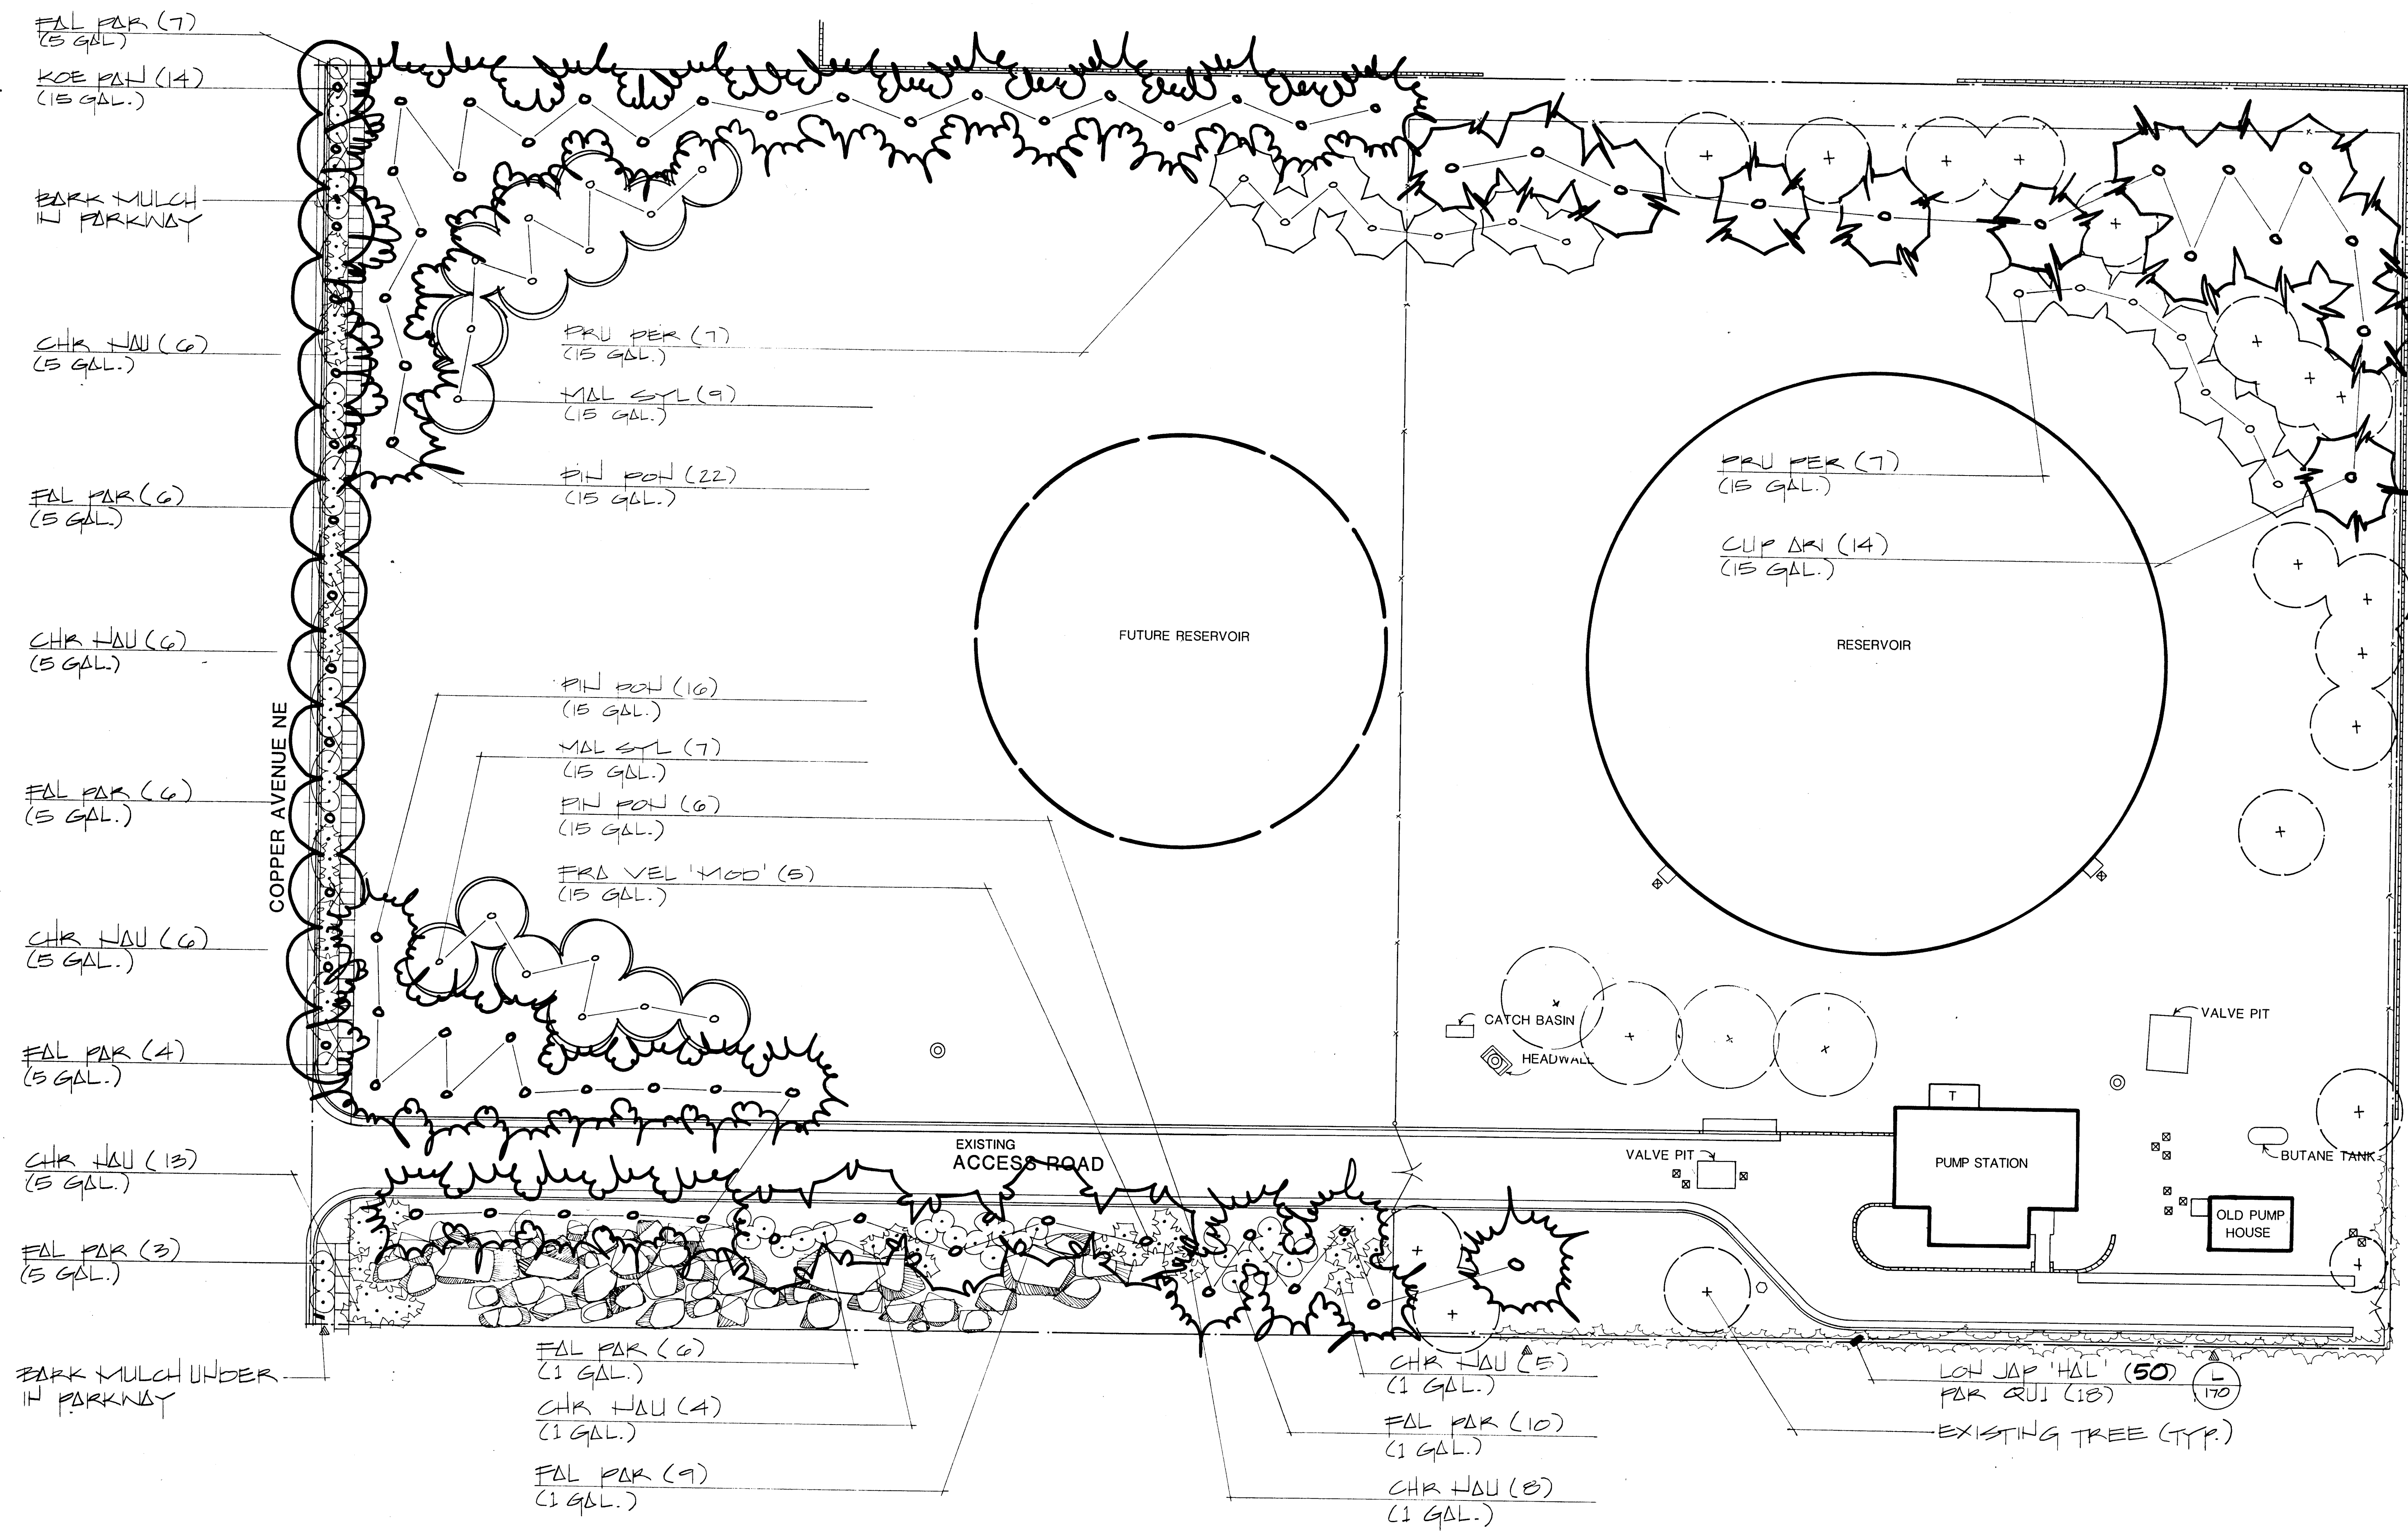

SCALE 1"=20'-0"

0 10 20 40

26 309710886

MORROW & COMPANY
LANDSCAPE ARCHITECTS
210 La Veta Drive NE
Albuquerque, New Mexico 87108
505-268-2266


NOVEMBER 1986

AS BUILT


SUPPER ROCK RESERVOIR & PUMP STATION
14529 MEL SMITH ROAD NE
PLANTING PLAN

LANDSCAPING IMPROVEMENTS FOR
WATER SYSTEM FACILITY SITES
CITY OF ALBUQUERQUE
ALBUQUERQUE, NEW MEXICO

SHEET
129
OF
172

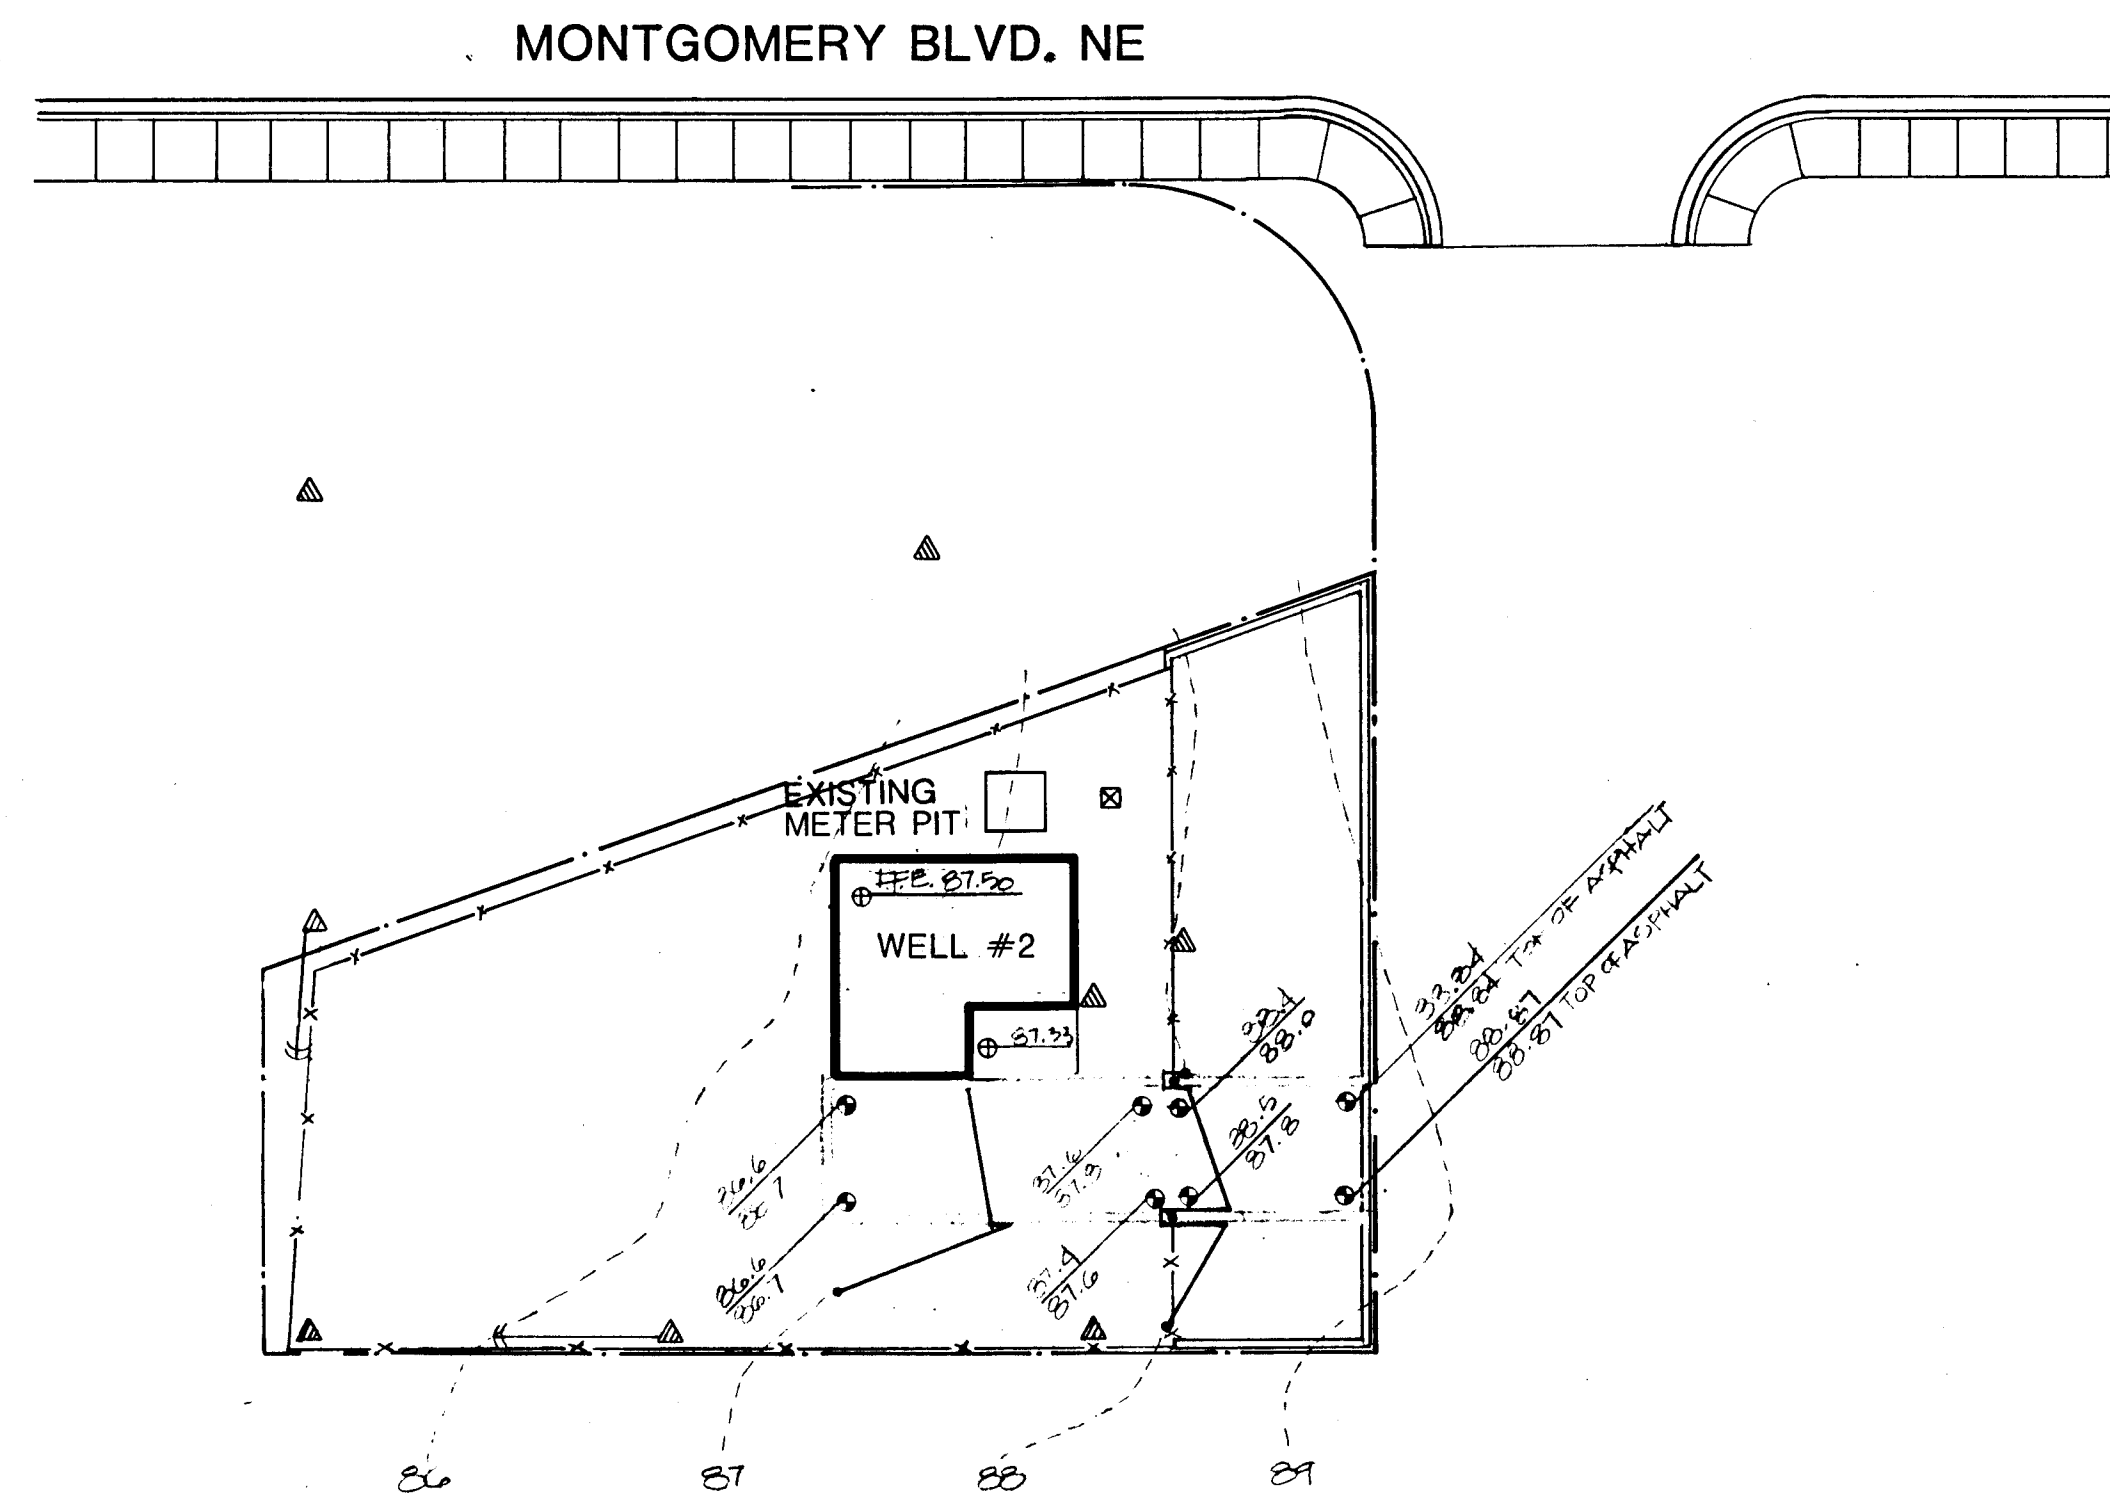

SCALE 1"=20'-0"

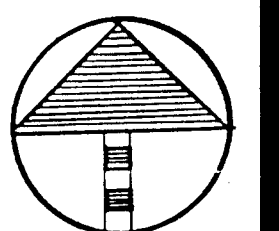

26 309710986

SHEET


LANDSCAPING IMPROVEMENTS FOR
WATER SYSTEM FACILITY SITES
WATER SYSTEMS DIVISION
CITY OF ALBUQUERQUE
ALBUQUERQUE, NEW MEXICO


THOMAS WELL #2
8924 A MONTGOMERY BLVD. NE
GRADING PLAN

AS BUILT

NOVEMBER
1986


MORROW & COMPANY
LANDSCAPE ARCHITECTS
210 La Veta Drive NE
Albuquerque, New Mexico 87108
505-268-2266

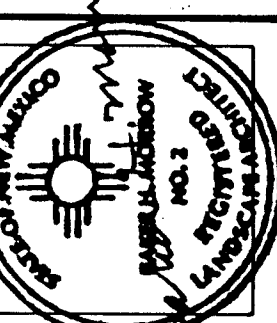

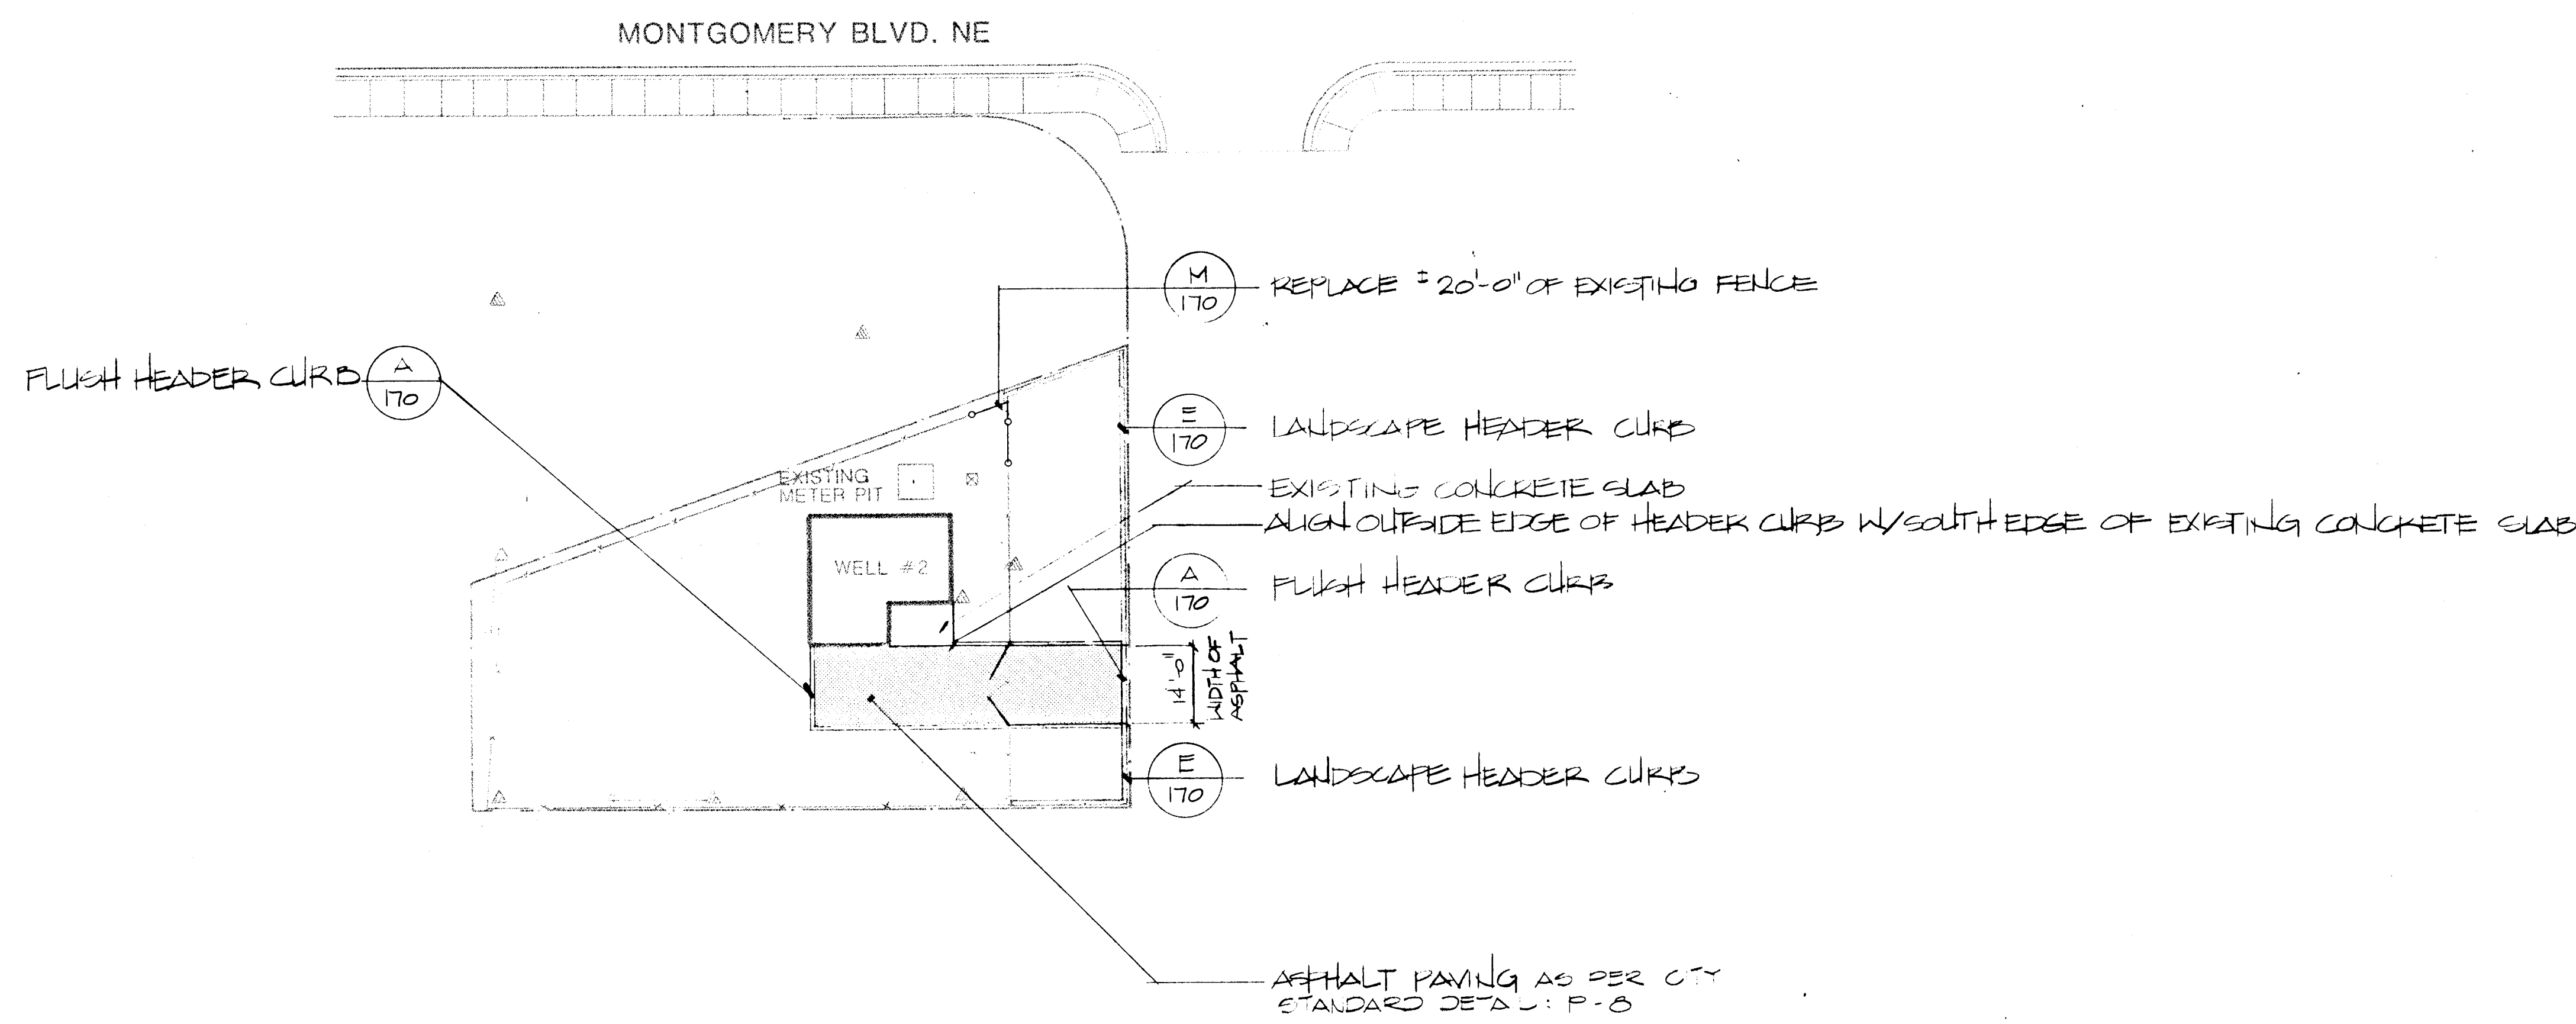

SCALE 1"=20'-0"

0 10 20 40

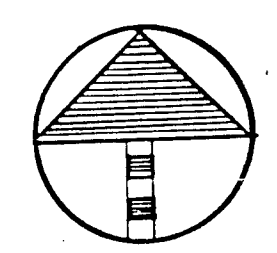

26 309711086

MORROW & COMPANY
 LANDSCAPE ARCHITECTS
 210 La Veta Drive NE
 Albuquerque, New Mexico 87108
 505-268-2266

LANDSCAPING IMPROVEMENTS FOR
WATER SYSTEM FACILITY SITES
 WATER SYSTEMS DIVISION
 CITY OF ALBUQUERQUE
 ALBUQUERQUE, NEW MEXICO



THOMAS WELL #2
 8924 A MONTGOMERY BLVD. NE
CONSTRUCTION PLAN

NOVEMBER
 1986


AS BUILT

SHEET
 131
 172


26 309711086

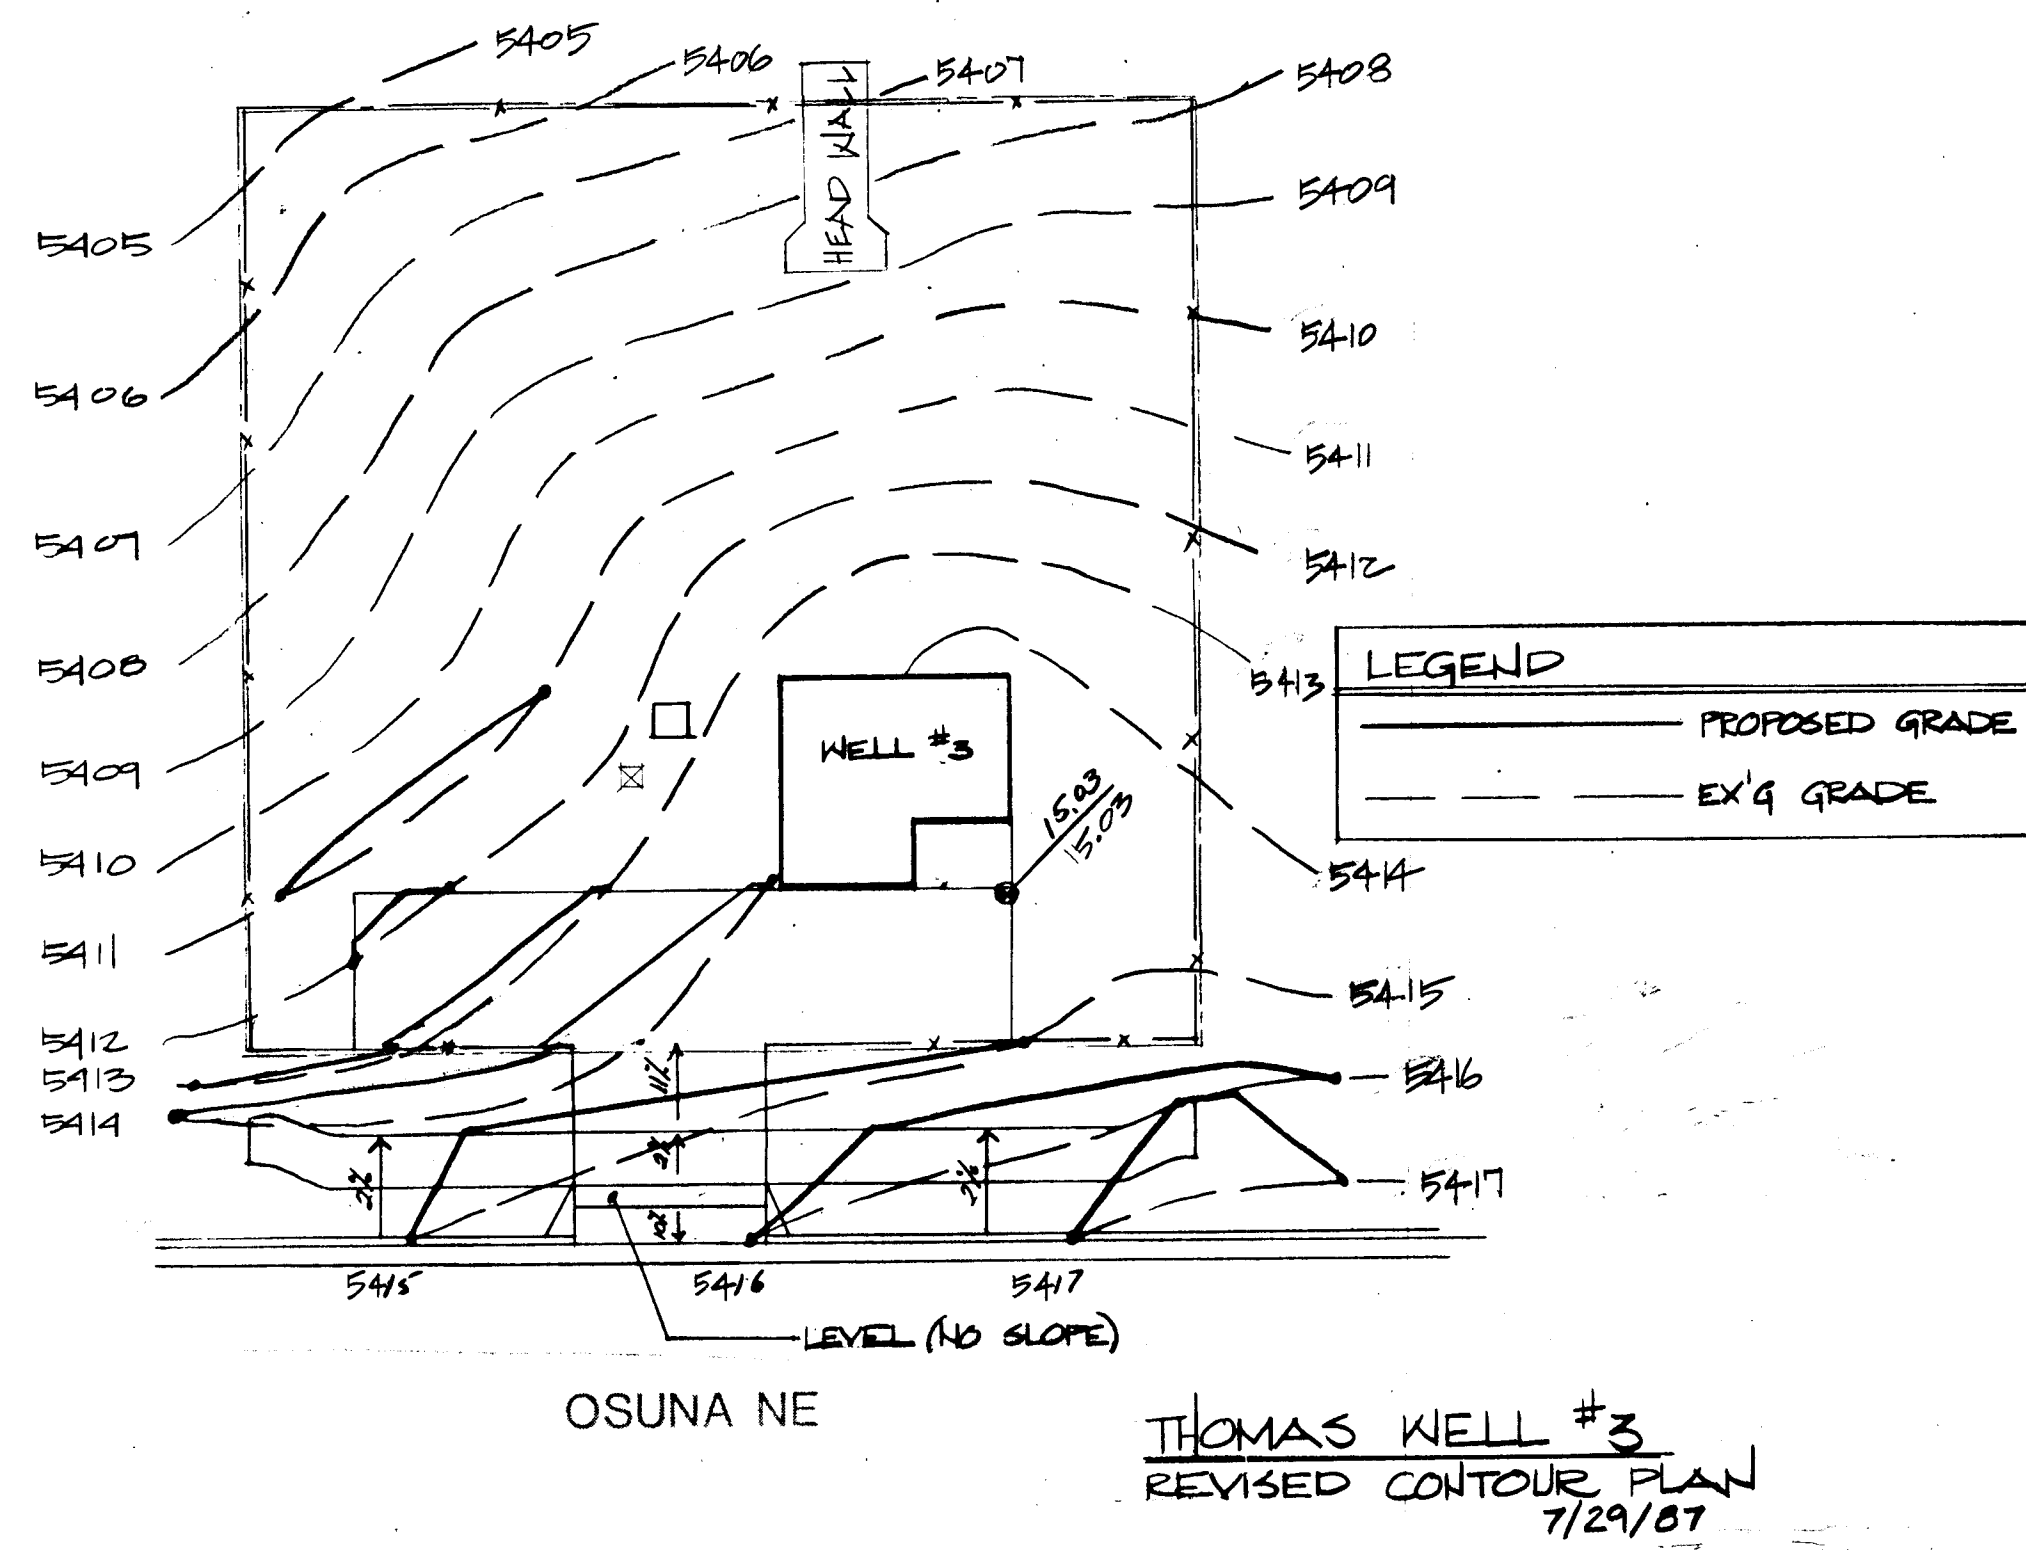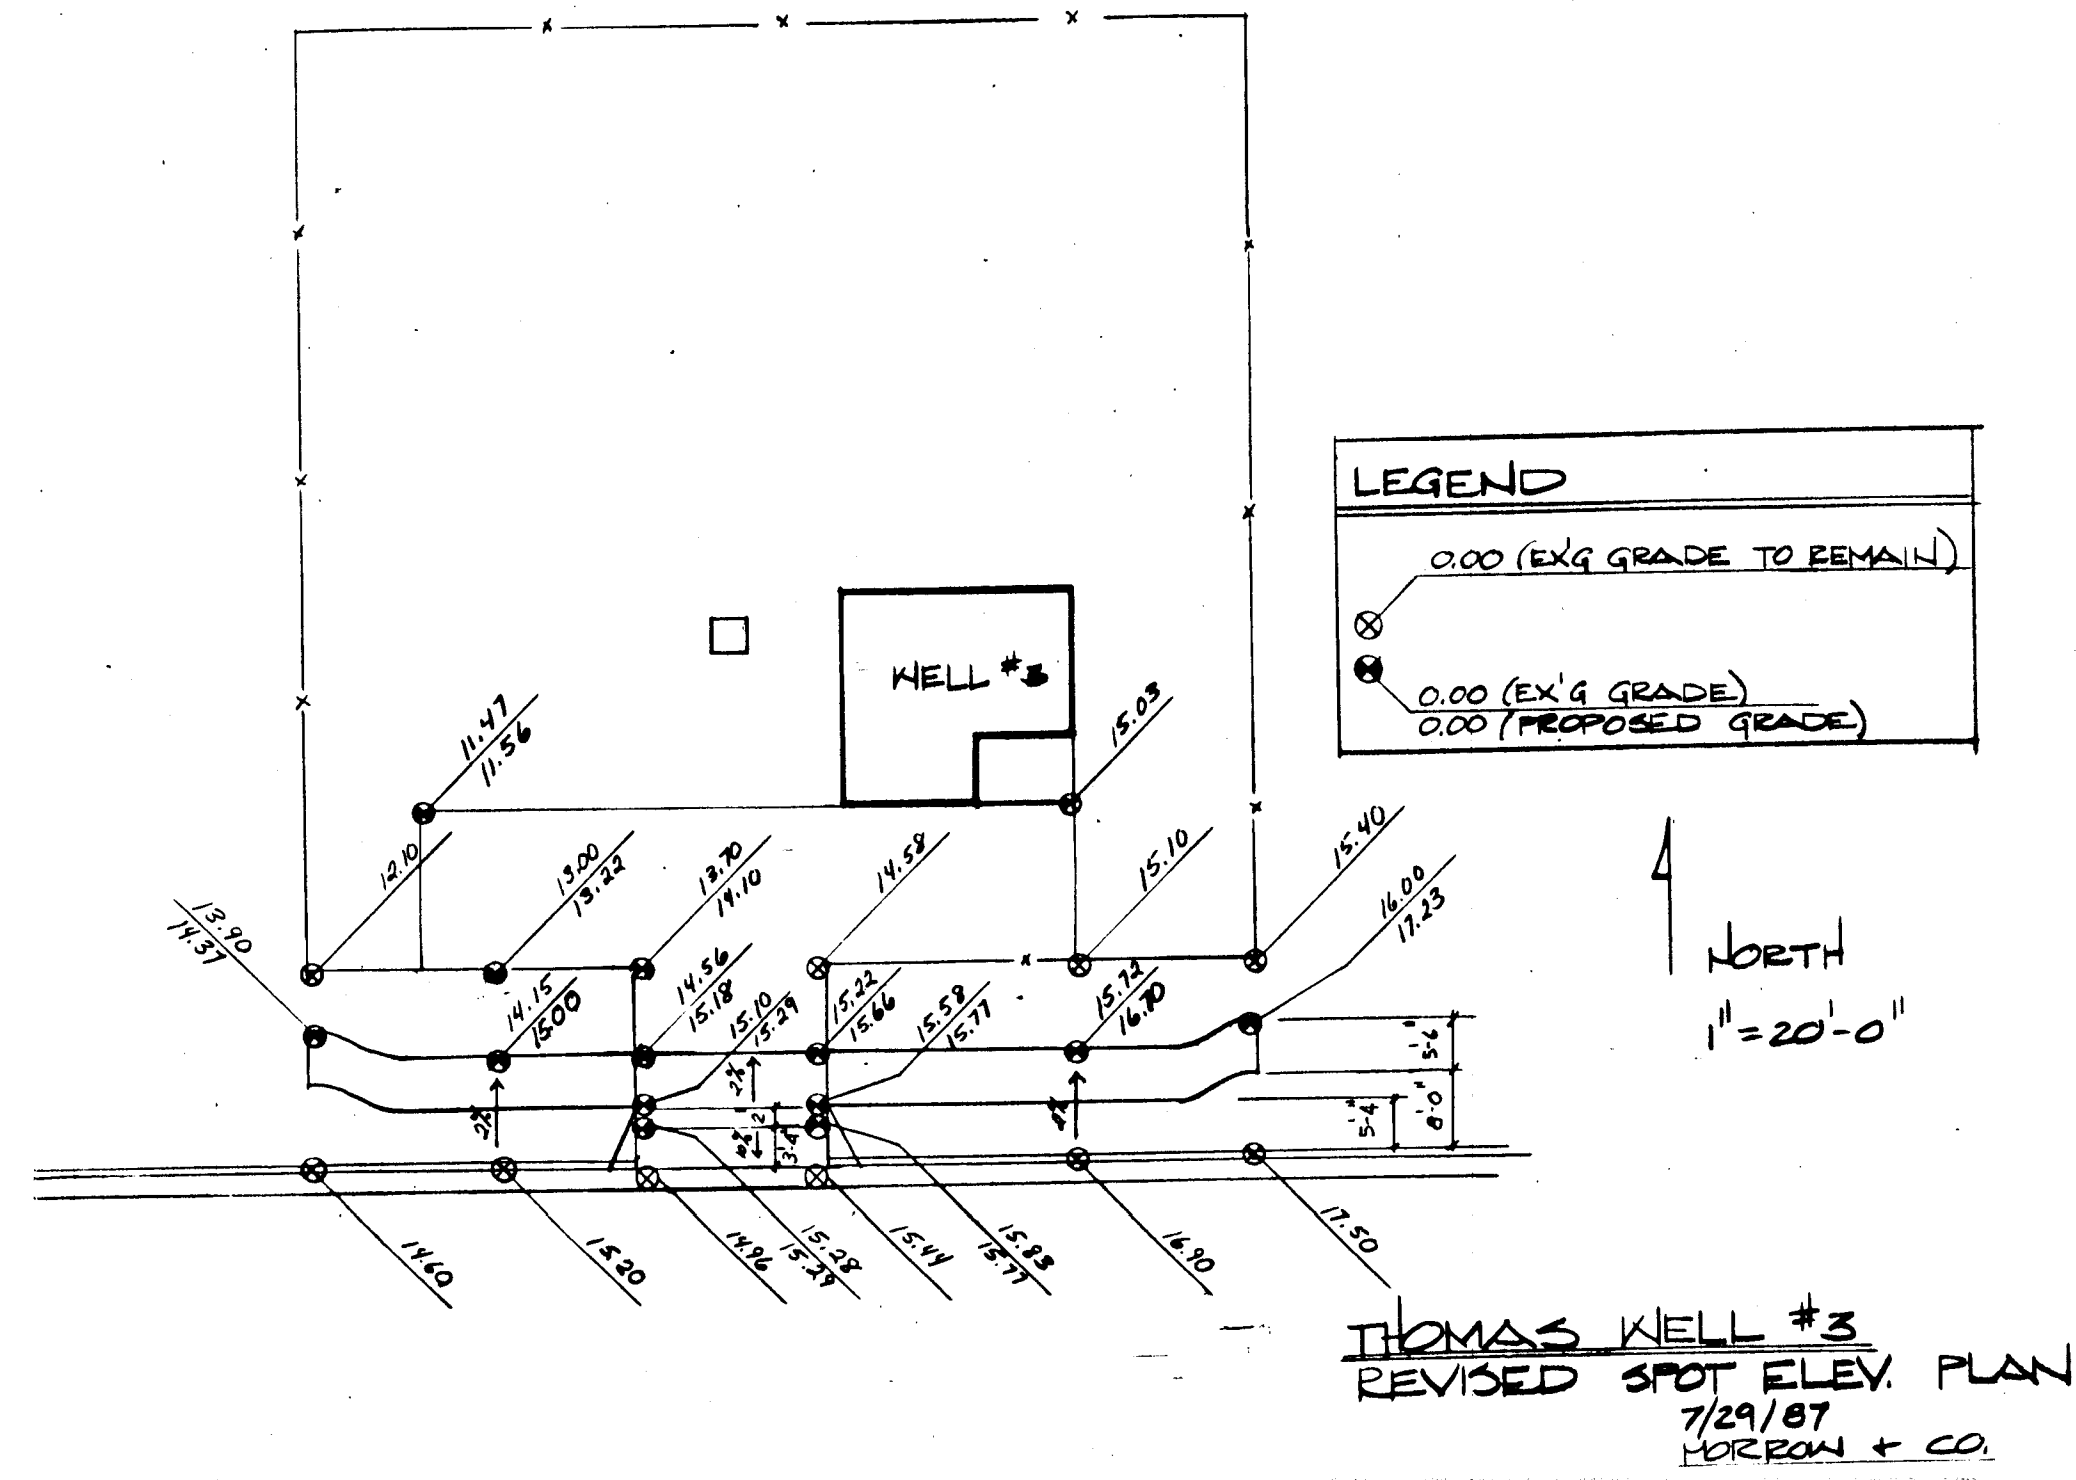

SCALE 1"=20'-0"

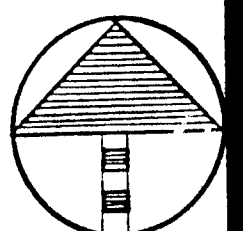

26 30971138C

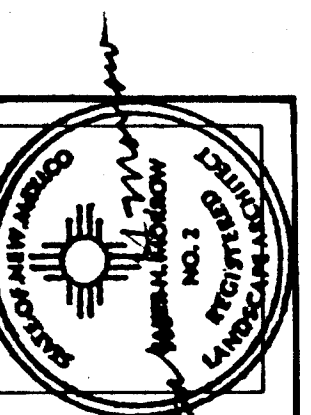

MORROW & COMPANY
LANDSCAPE ARCHITECTS
210 La Veta Drive NE
Albuquerque, New Mexico 87108
505-268-2266


NOVEMBER
1986

AS BUILT

LANDSCAPING IMPROVEMENTS FOR
WATER SYSTEM FACILITY SITES
WATER SYSTEMS DIVISION
CITY OF ALBUQUERQUE
ALBUQUERQUE, NEW MEXICO

THOMAS WELL #3
7907 OSUNA ROAD NE
GRADING PLAN

SHEET
134
OF
172

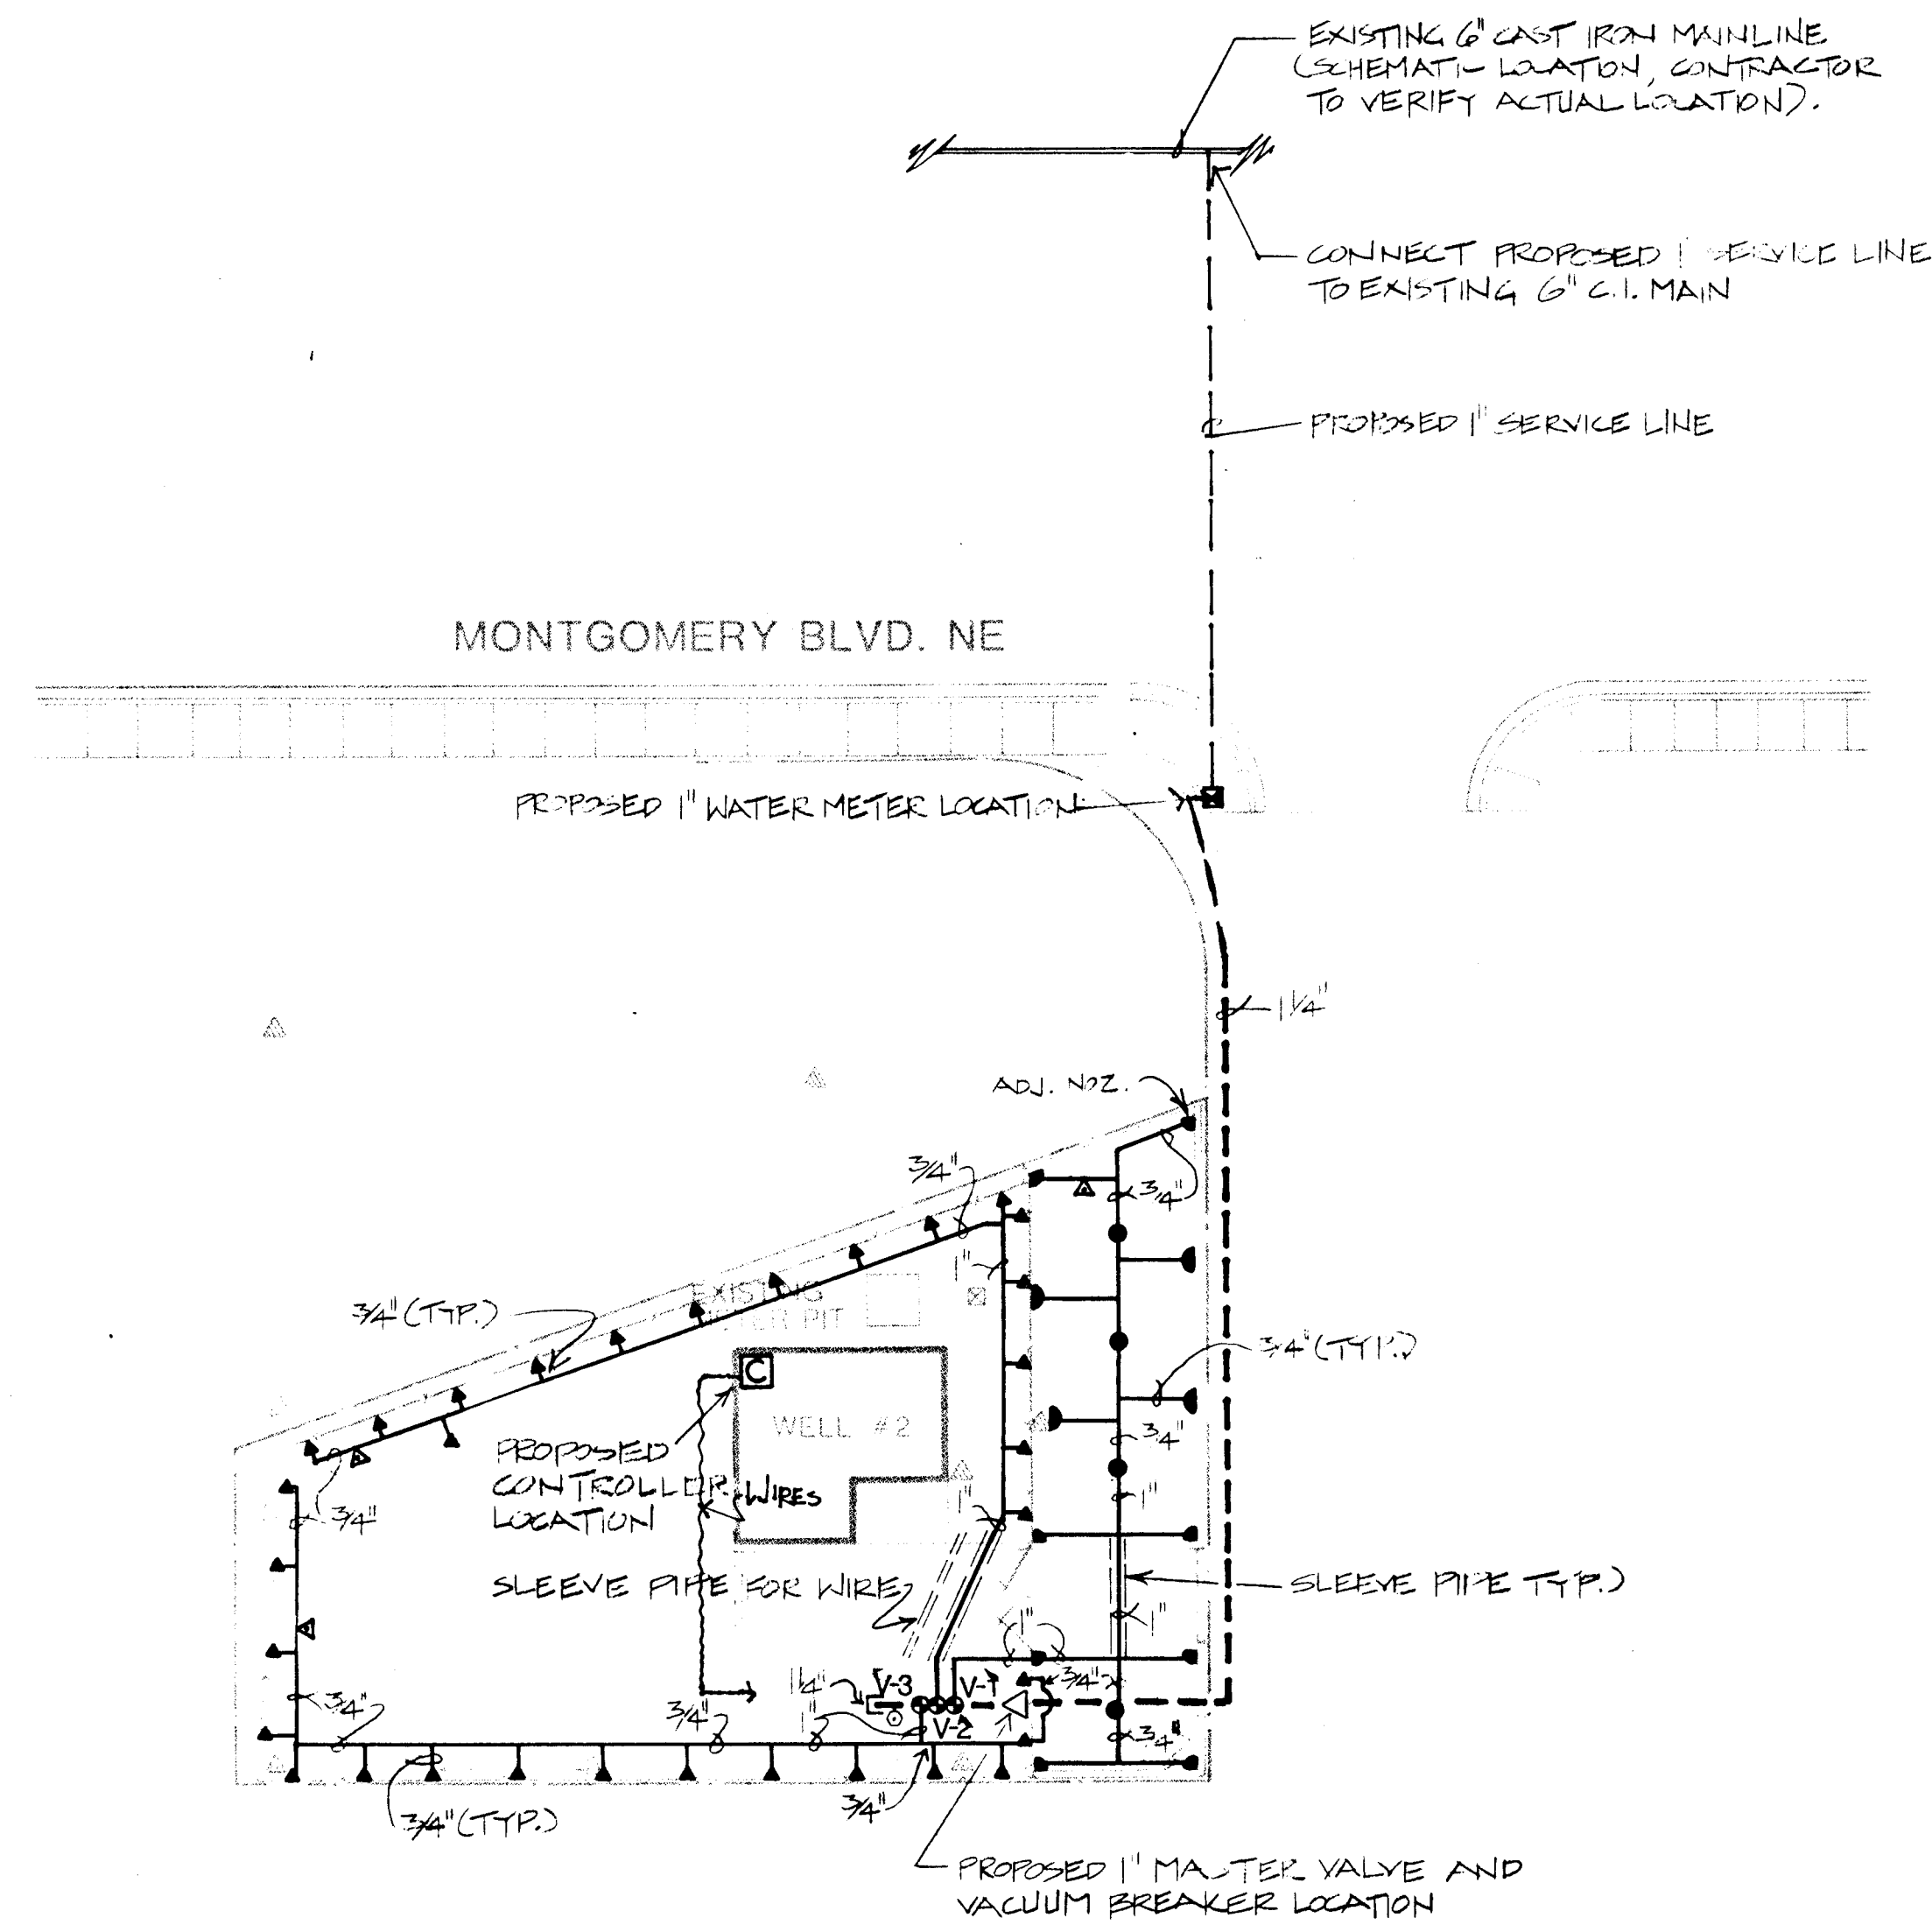

ELECTRICAL PANEL →

← IRRIGATION CONTROLLER

CIRCUIT # 11

3/4" RIGID STEEL CONDUIT, 110 VOLT CONDUIT →



1/2" RIGID STEEL CONDUIT, 24 VOLT CIRCUITS
TO REMOTE CONTROL VALVES. →

SCHEMATIC AS BUILT FOR 110 VOLT ELECTRICAL
FROM SOURCE TO IRRIGATION CONTROLLER

SCALE 1"=20'-0"

0 10 20 40

26 309711186

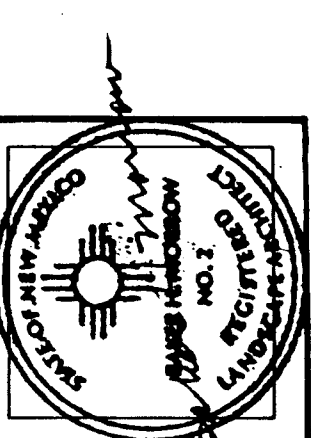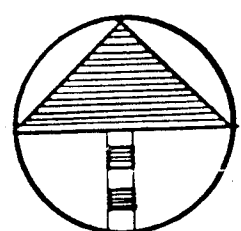

MORROW & COMPANY
LANDSCAPE ARCHITECTS
210 La Veta Drive NE
Albuquerque, New Mexico 87108
505-268-2266




NOVEMBER
1986

AS BUILT

THOMAS WELL #2
8924 A MONTGOMERY BLVD. NE
IRRIGATION PLAN


LANDSCAPING IMPROVEMENTS FOR
WATER SYSTEM FACILITY SITES
WATER SYSTEMS DIVISION
CITY OF ALBUQUERQUE
ALBUQUERQUE, NEW MEXICO

SHEET
130
27
172

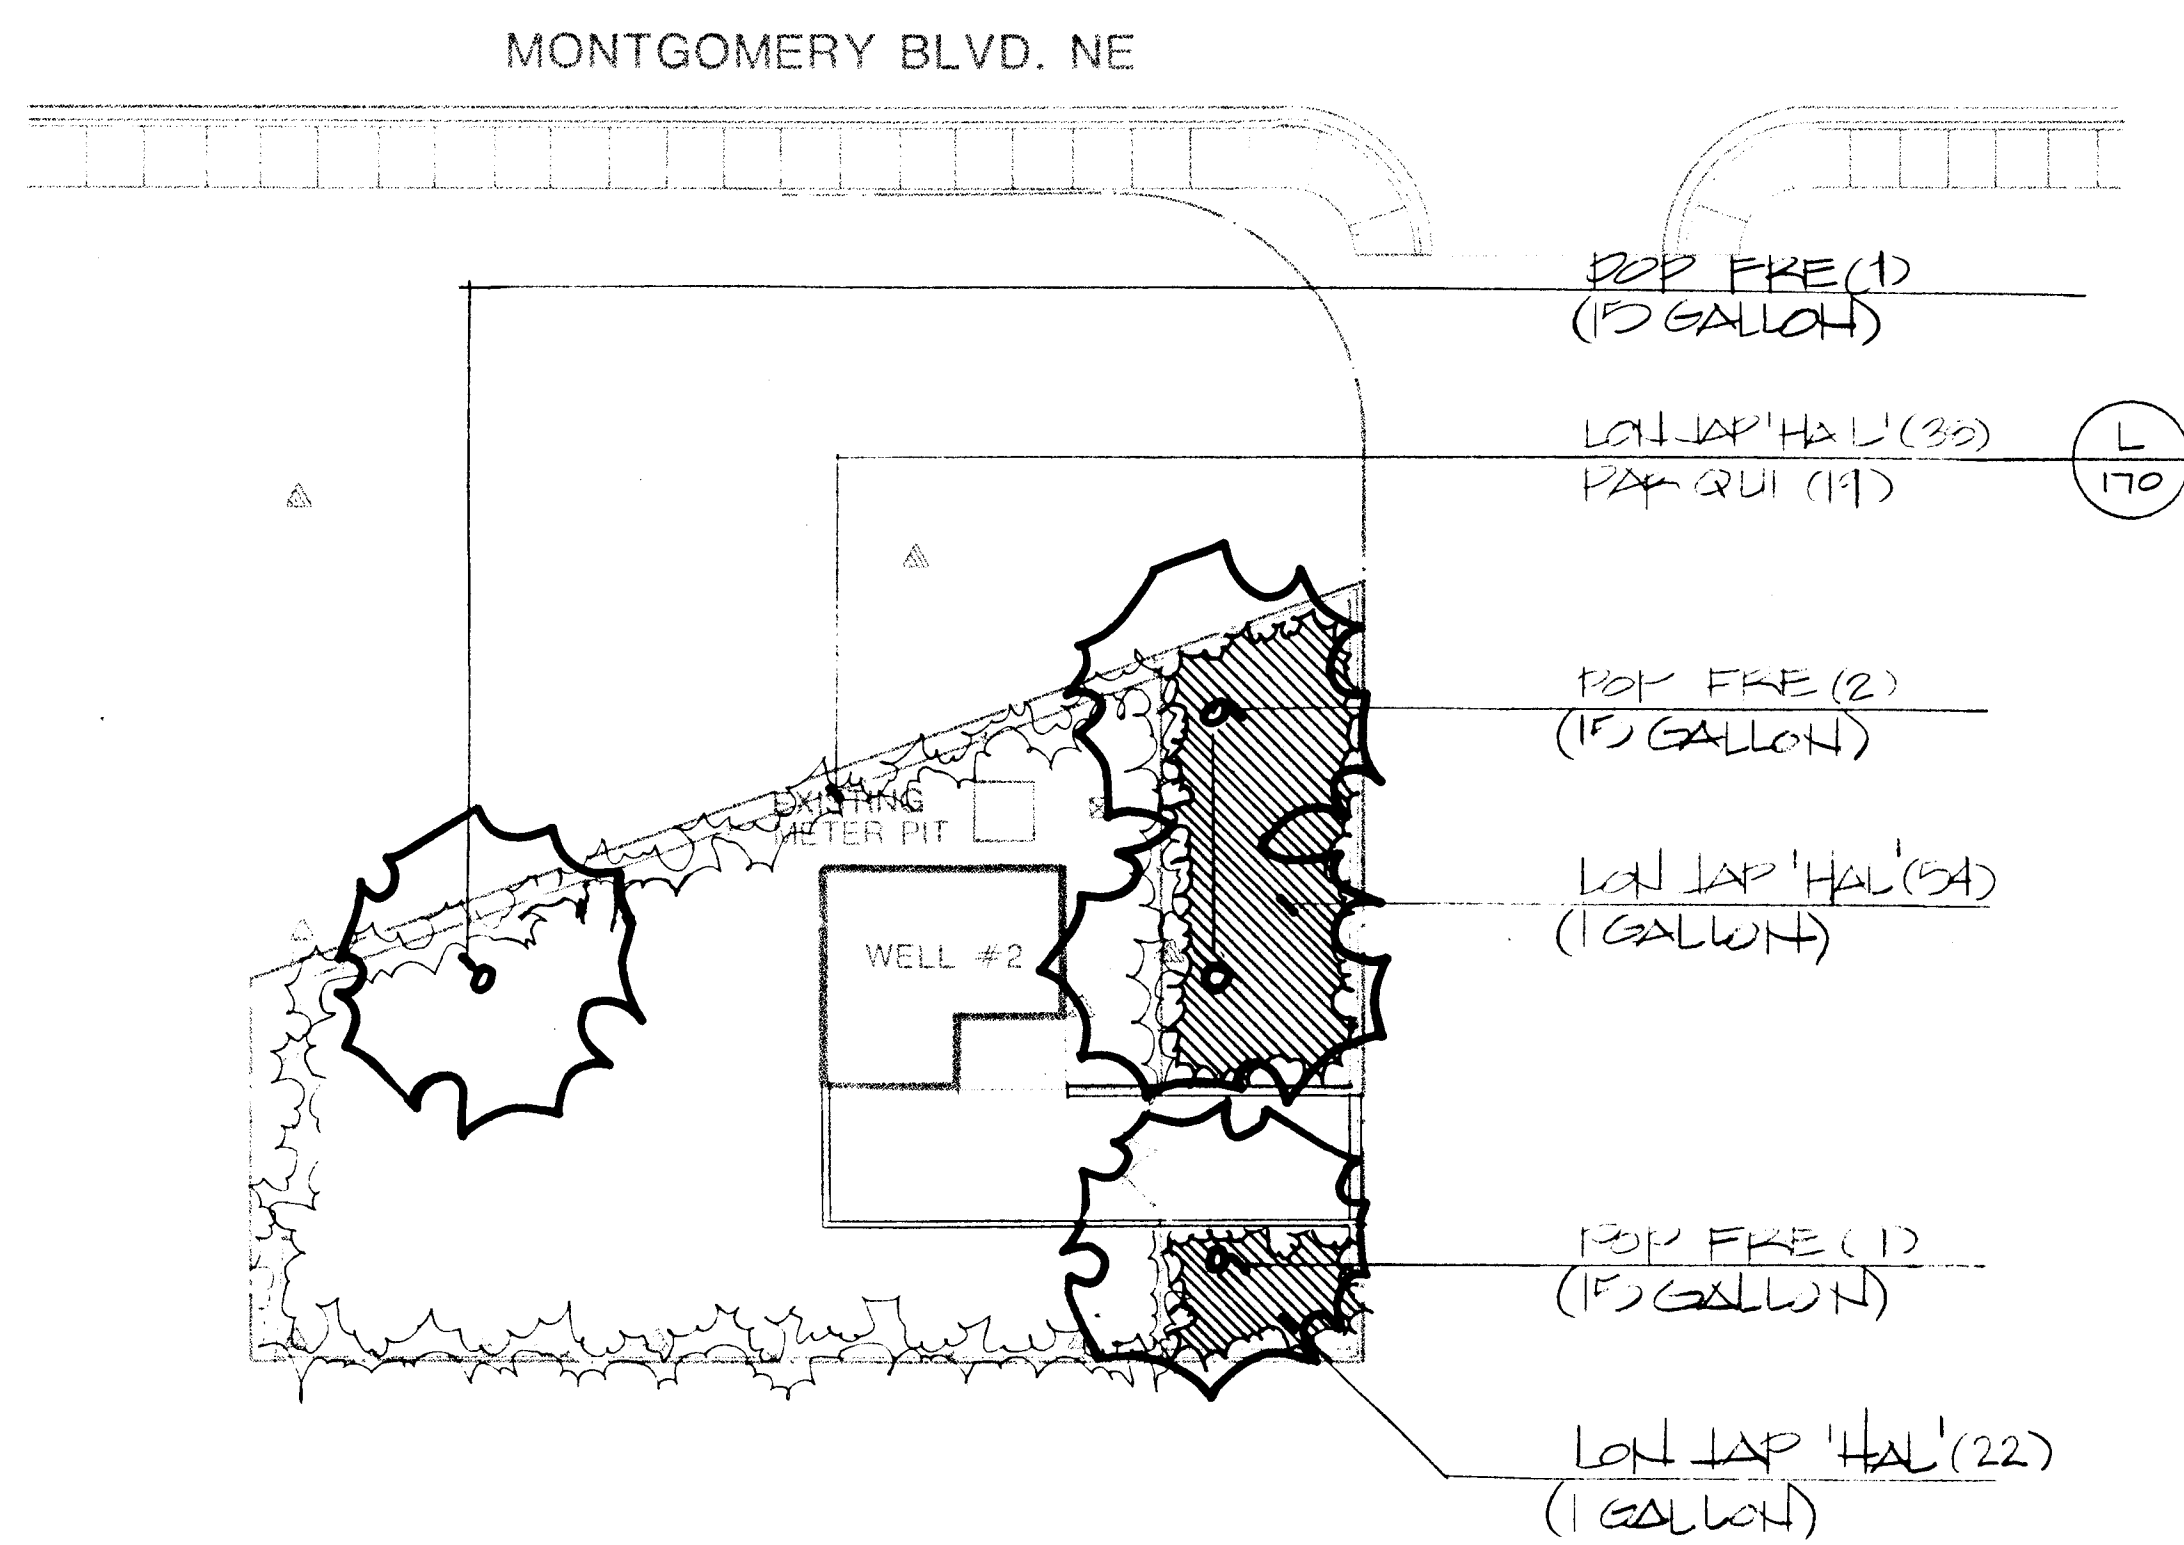


SCALE 1"=20'-0"

0 10 20 40

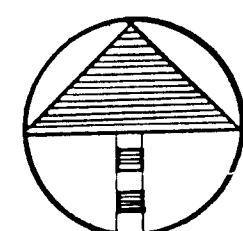

26 309711286

MORROW & COMPANY
LANDSCAPE ARCHITECTS
210 La Veta Drive NE
Albuquerque, New Mexico 87108
505-268-2266

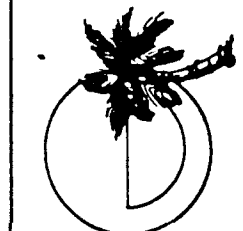


NOVEMBER
1986

THOMAS WELL #2
8924 A MONTGOMERY BLVD. NE
PLANTING PLAN


LANDSCAPING IMPROVEMENTS FOR
WATER SYSTEM FACILITY SITES
WATER SYSTEMS DIVISION
CITY OF ALBUQUERQUE
ALBUQUERQUE, NEW MEXICO

SHEET
13
12

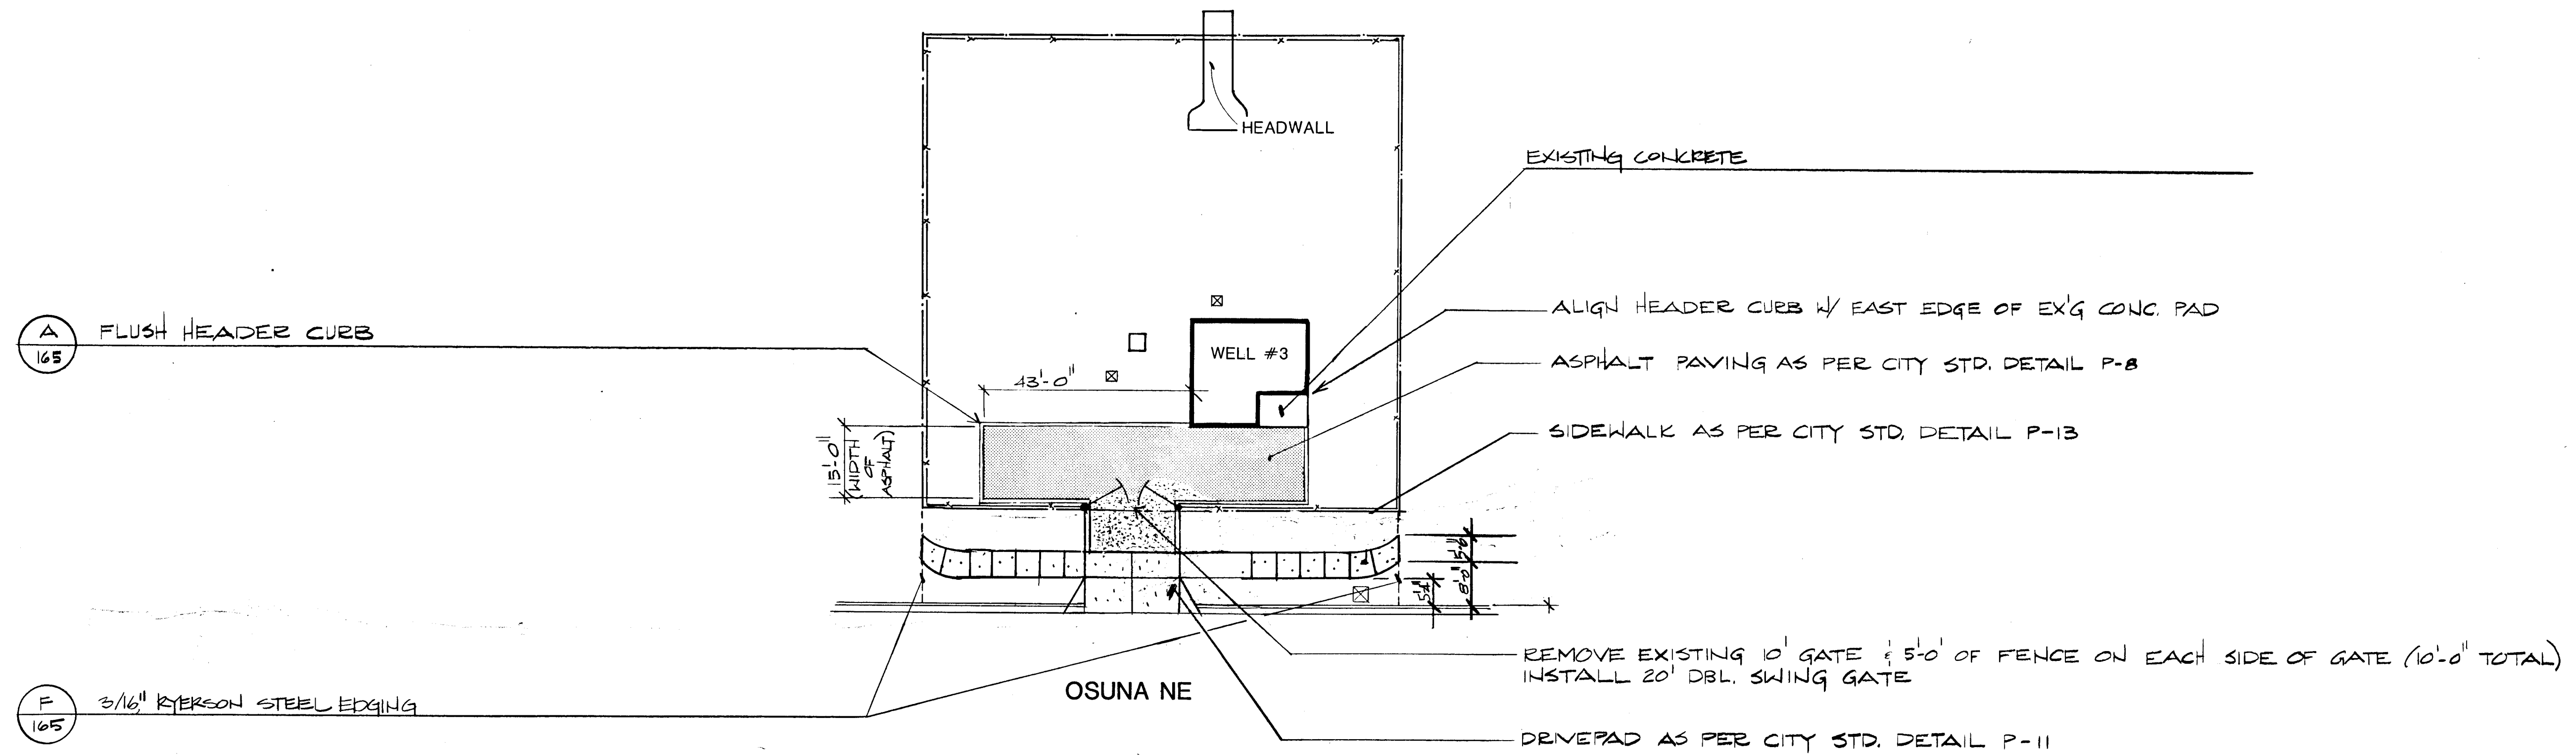

SCALE 1"=20'-0"

0 10 20 40

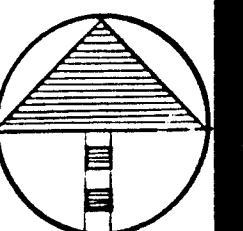

26 309711486



MORROW & COMPANY
LANDSCAPE ARCHITECTS
210 La Veta Drive NE
Albuquerque, New Mexico 87108
505-268-2266




NOVEMBER
1986

AS BUILT

THOMAS WELL #3
7907 OSUNA ROAD NE
CONSTRUCTION PLAN

LANDSCAPING IMPROVEMENTS FOR
WATER SYSTEM FACILITY SITES
WATER SYSTEMS DIVISION
CITY OF ALBUQUERQUE
ALBUQUERQUE, NEW MEXICO


SHEET
135
136
137

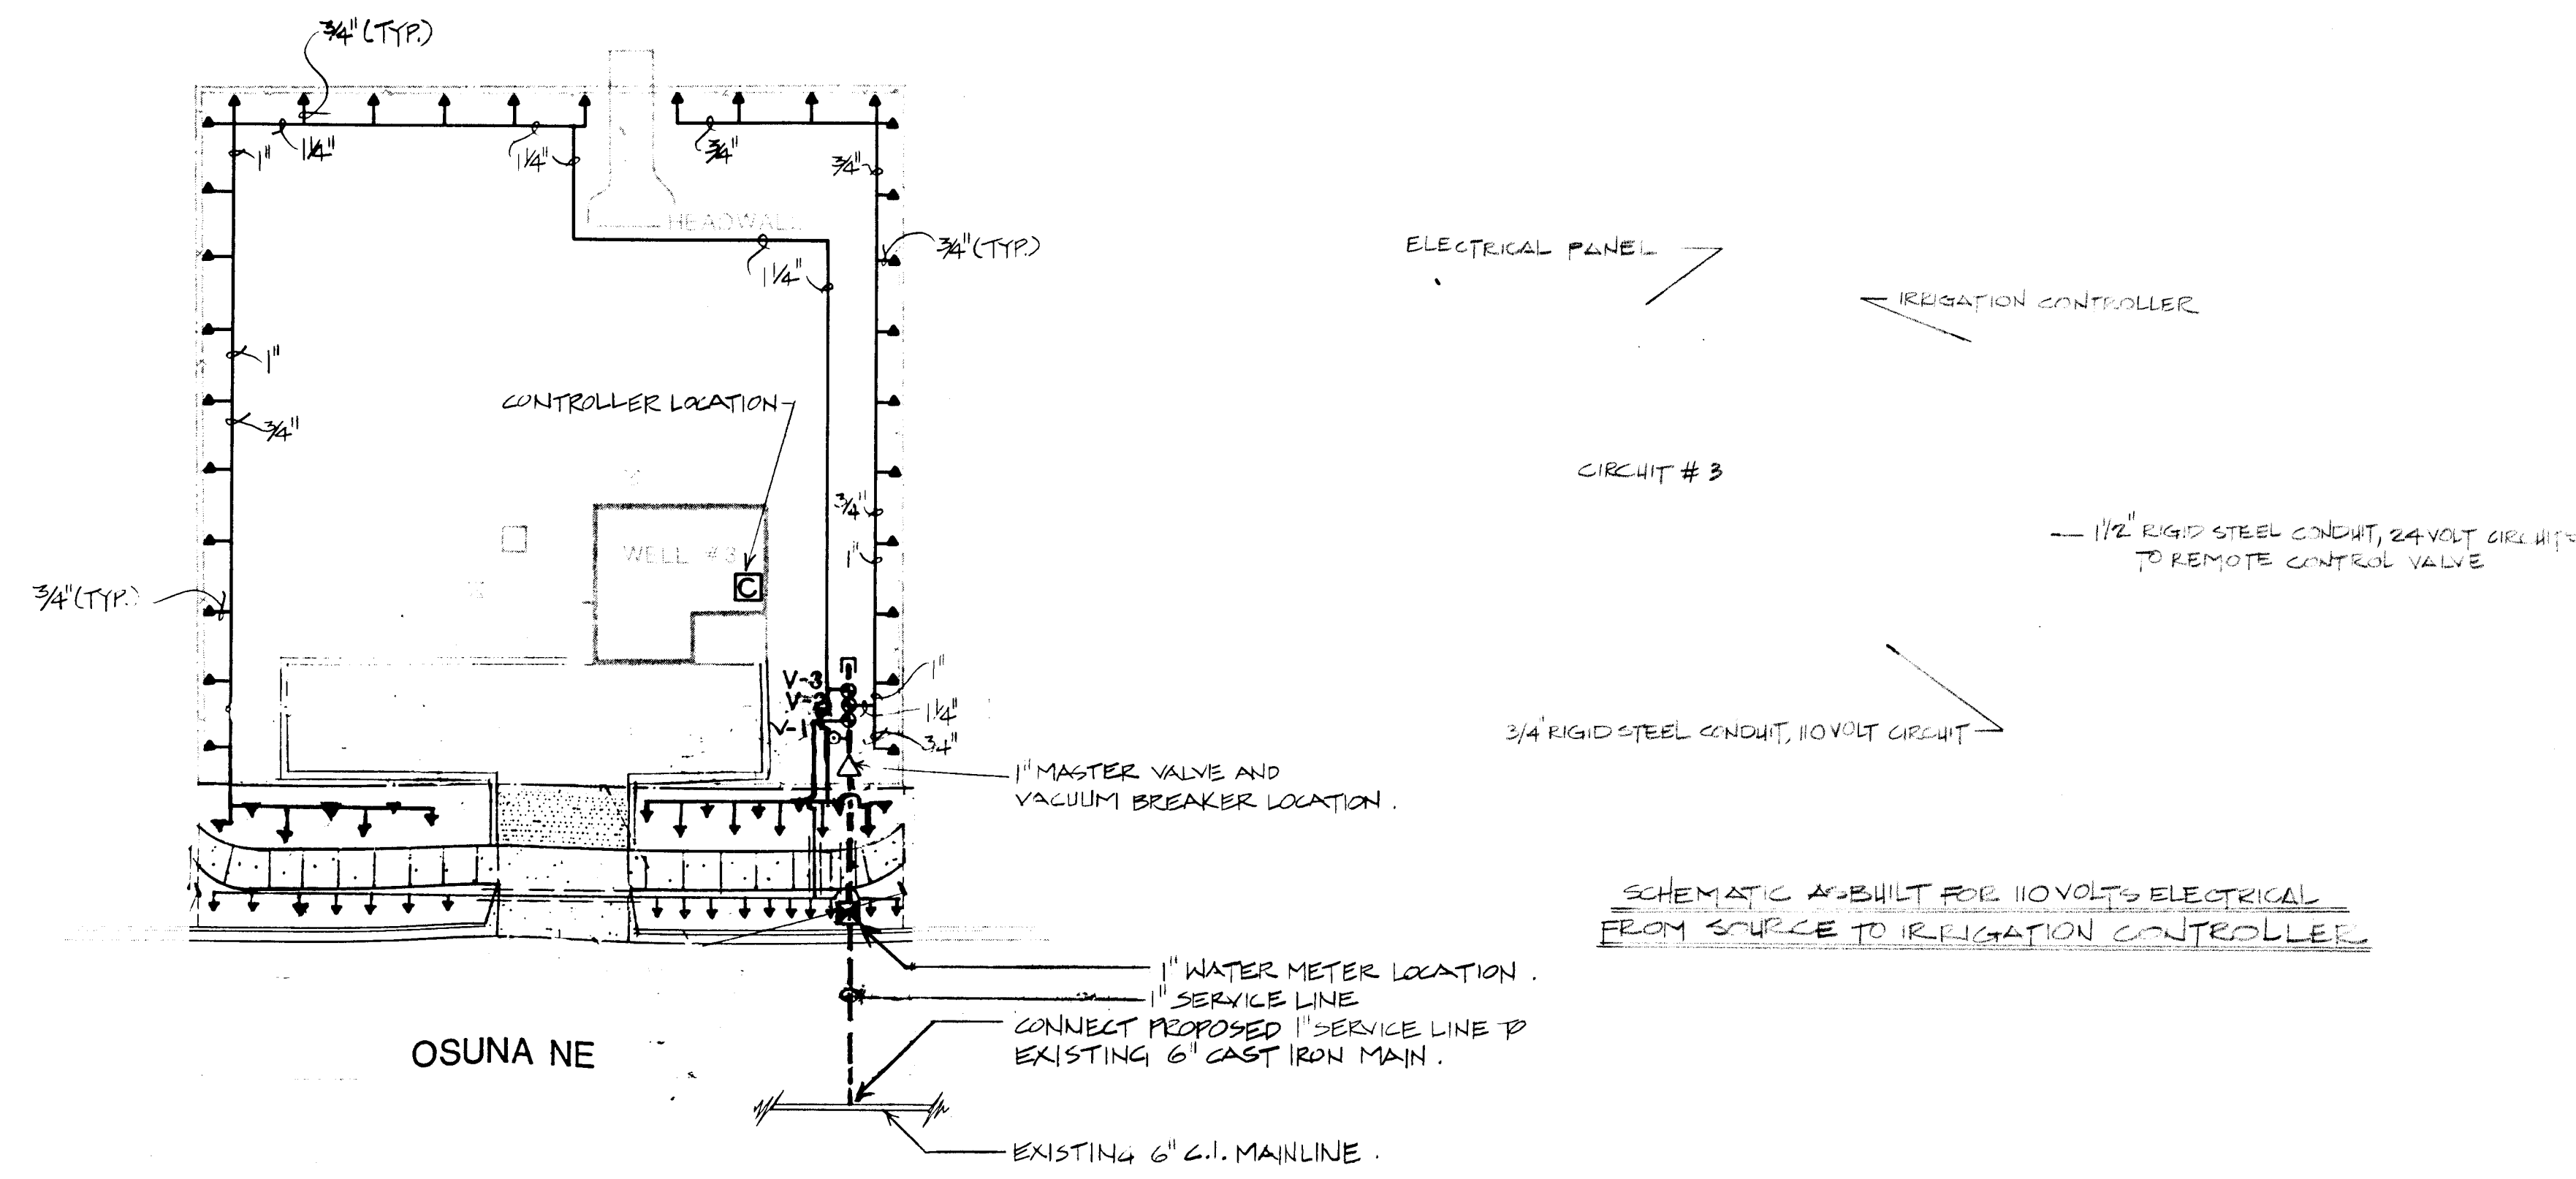


SCHEMATIC AS-BUILT FOR 110 VOLTS ELECTRICAL FROM SOURCE TO IRRIGATION CONTROLLER

SCALE 1"=20'-0"


0 10 20 40

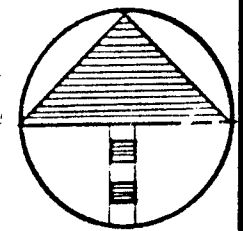

26 30.9711586

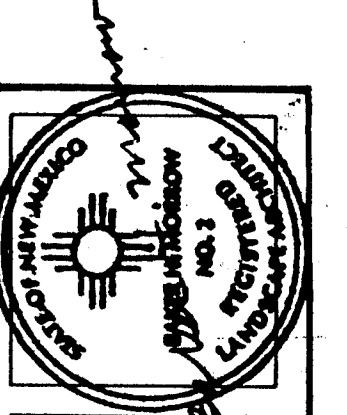

MORROW & COMPANY
 LANDSCAPE ARCHITECTS
 210 La Veta Drive NE
 Albuquerque, New Mexico 87108
 505-268-2266

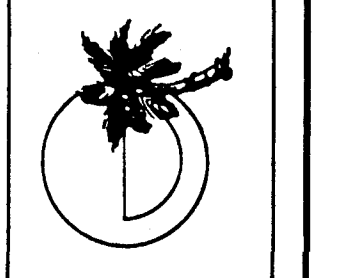


NOVEMBER
 1986

AS BUILT


THOMAS WELL #3
 7907 OSUNA ROAD NE
 IRRIGATION PLAN

LANDSCAPING IMPROVEMENTS FOR
WATER SYSTEM FACILITY SITES
 WATER SYSTEMS DIVISION
 CITY OF ALBUQUERQUE
 ALBUQUERQUE, NEW MEXICO


SHEET
 13
 96
 172

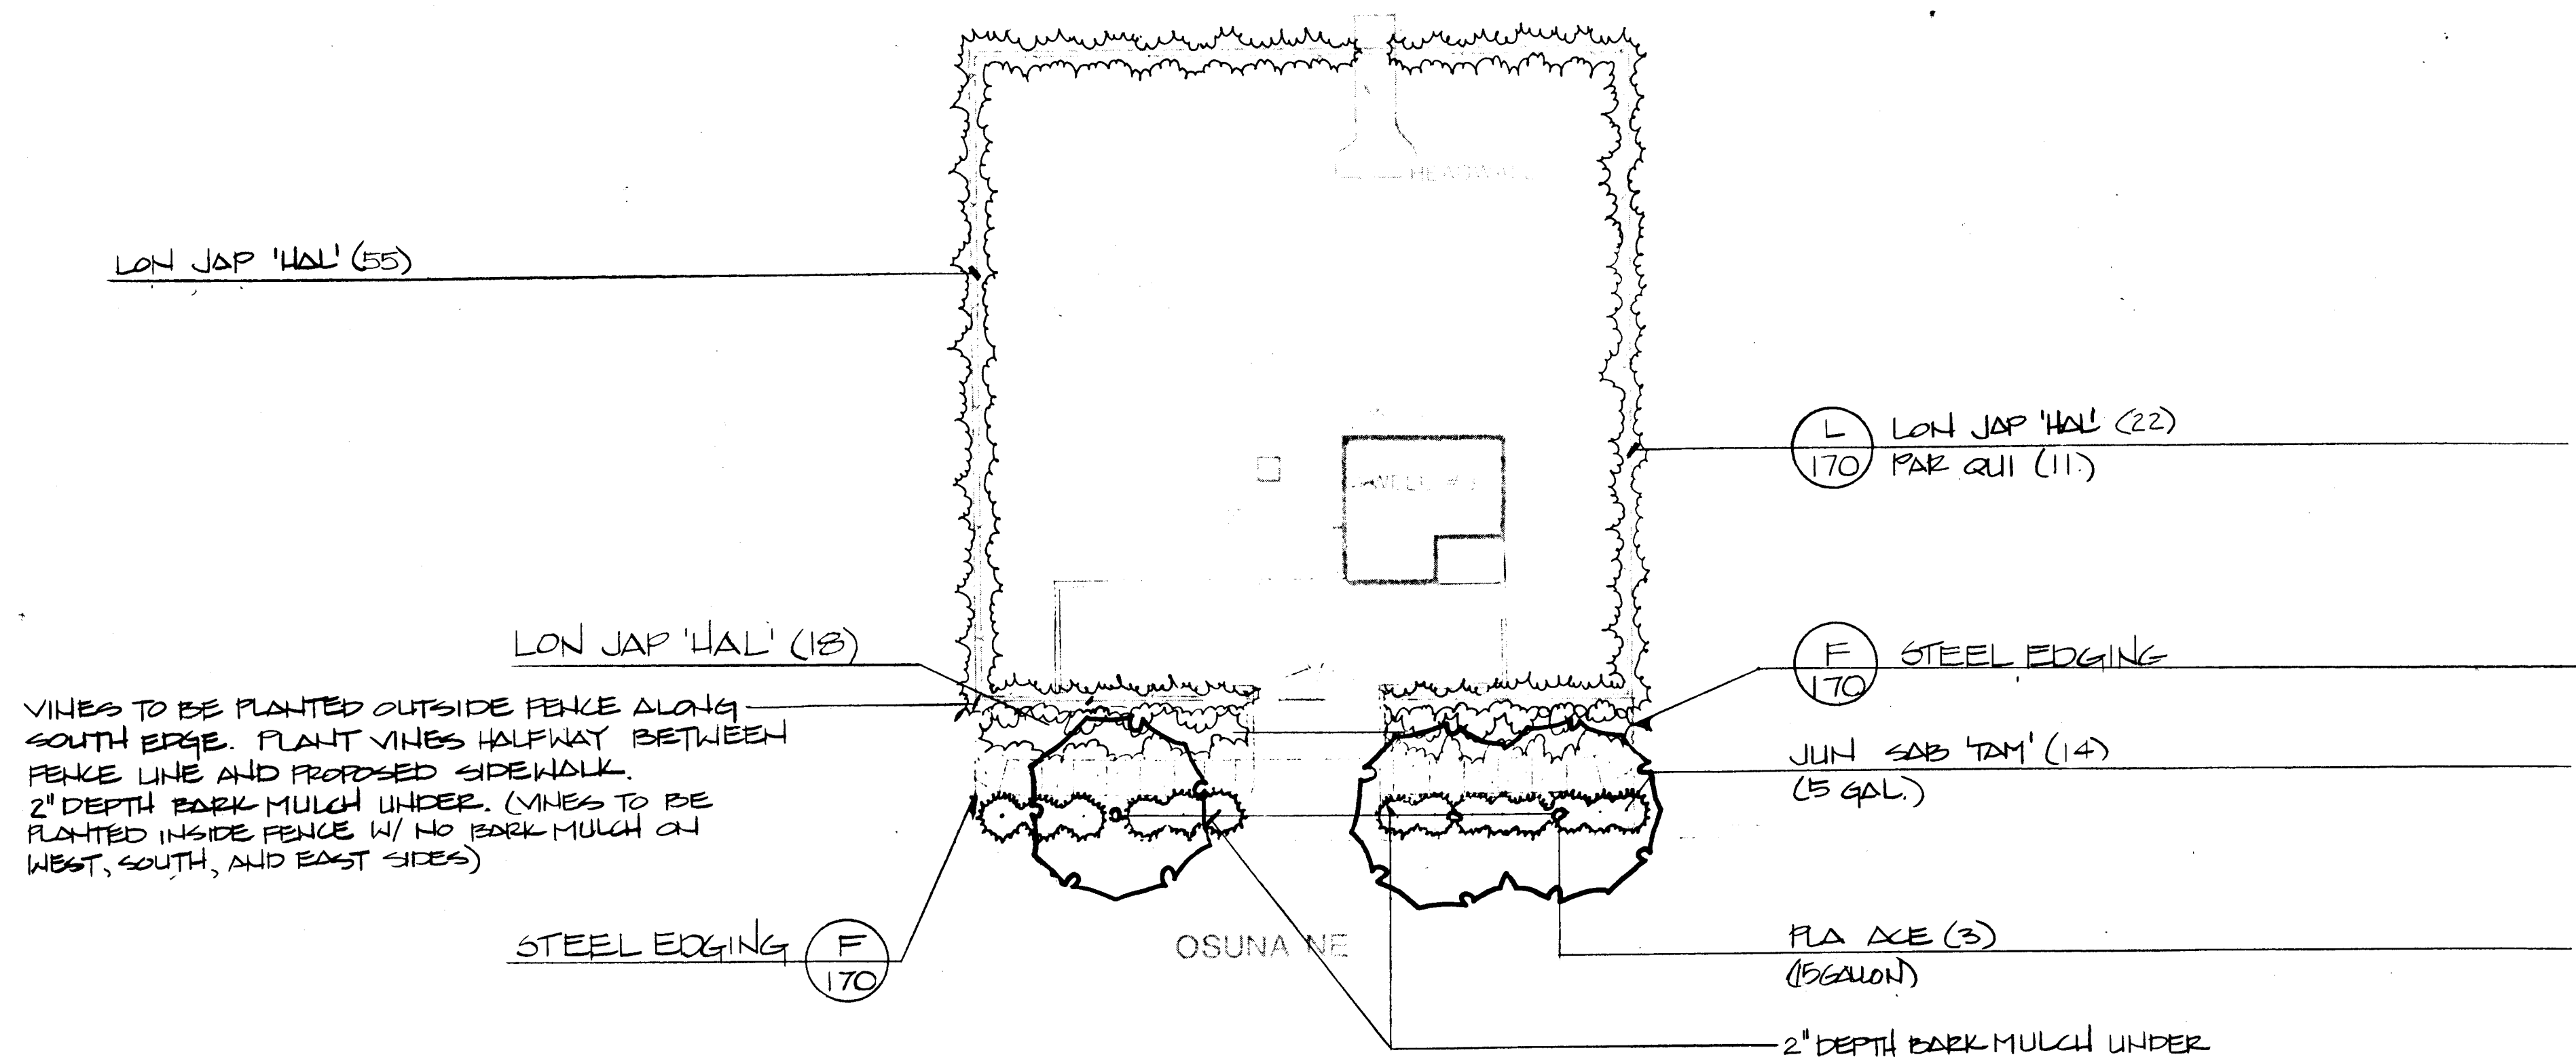

SCALE 1"=20'-0"

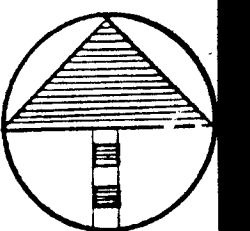

26 309711686

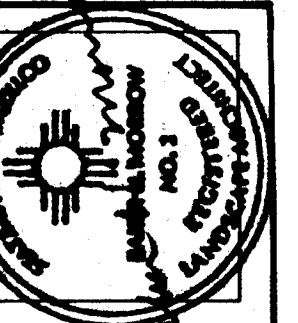

MORROW & COMPANY
LANDSCAPE ARCHITECTS
210 La Veta Drive NE
Albuquerque, New Mexico 87108
505-268-2266





NOVEMBER
1986


AS BUILT

THOMAS WELL #3
7907 OSUNA ROAD NE
PLANTING PLAN

LANDSCAPING IMPROVEMENTS FOR
WATER SYSTEM FACILITY SITES
WATER SYSTEMS DIVISION
CITY OF ALBUQUERQUE
ALBUQUERQUE, NEW MEXICO


SHEET
137
137
137

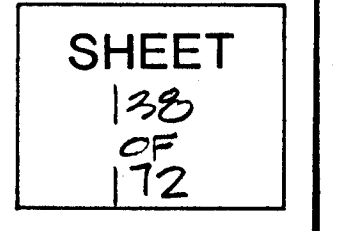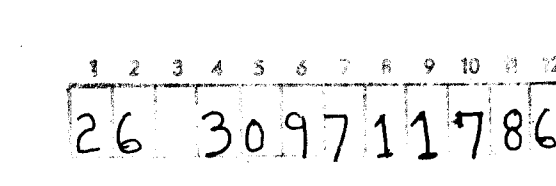

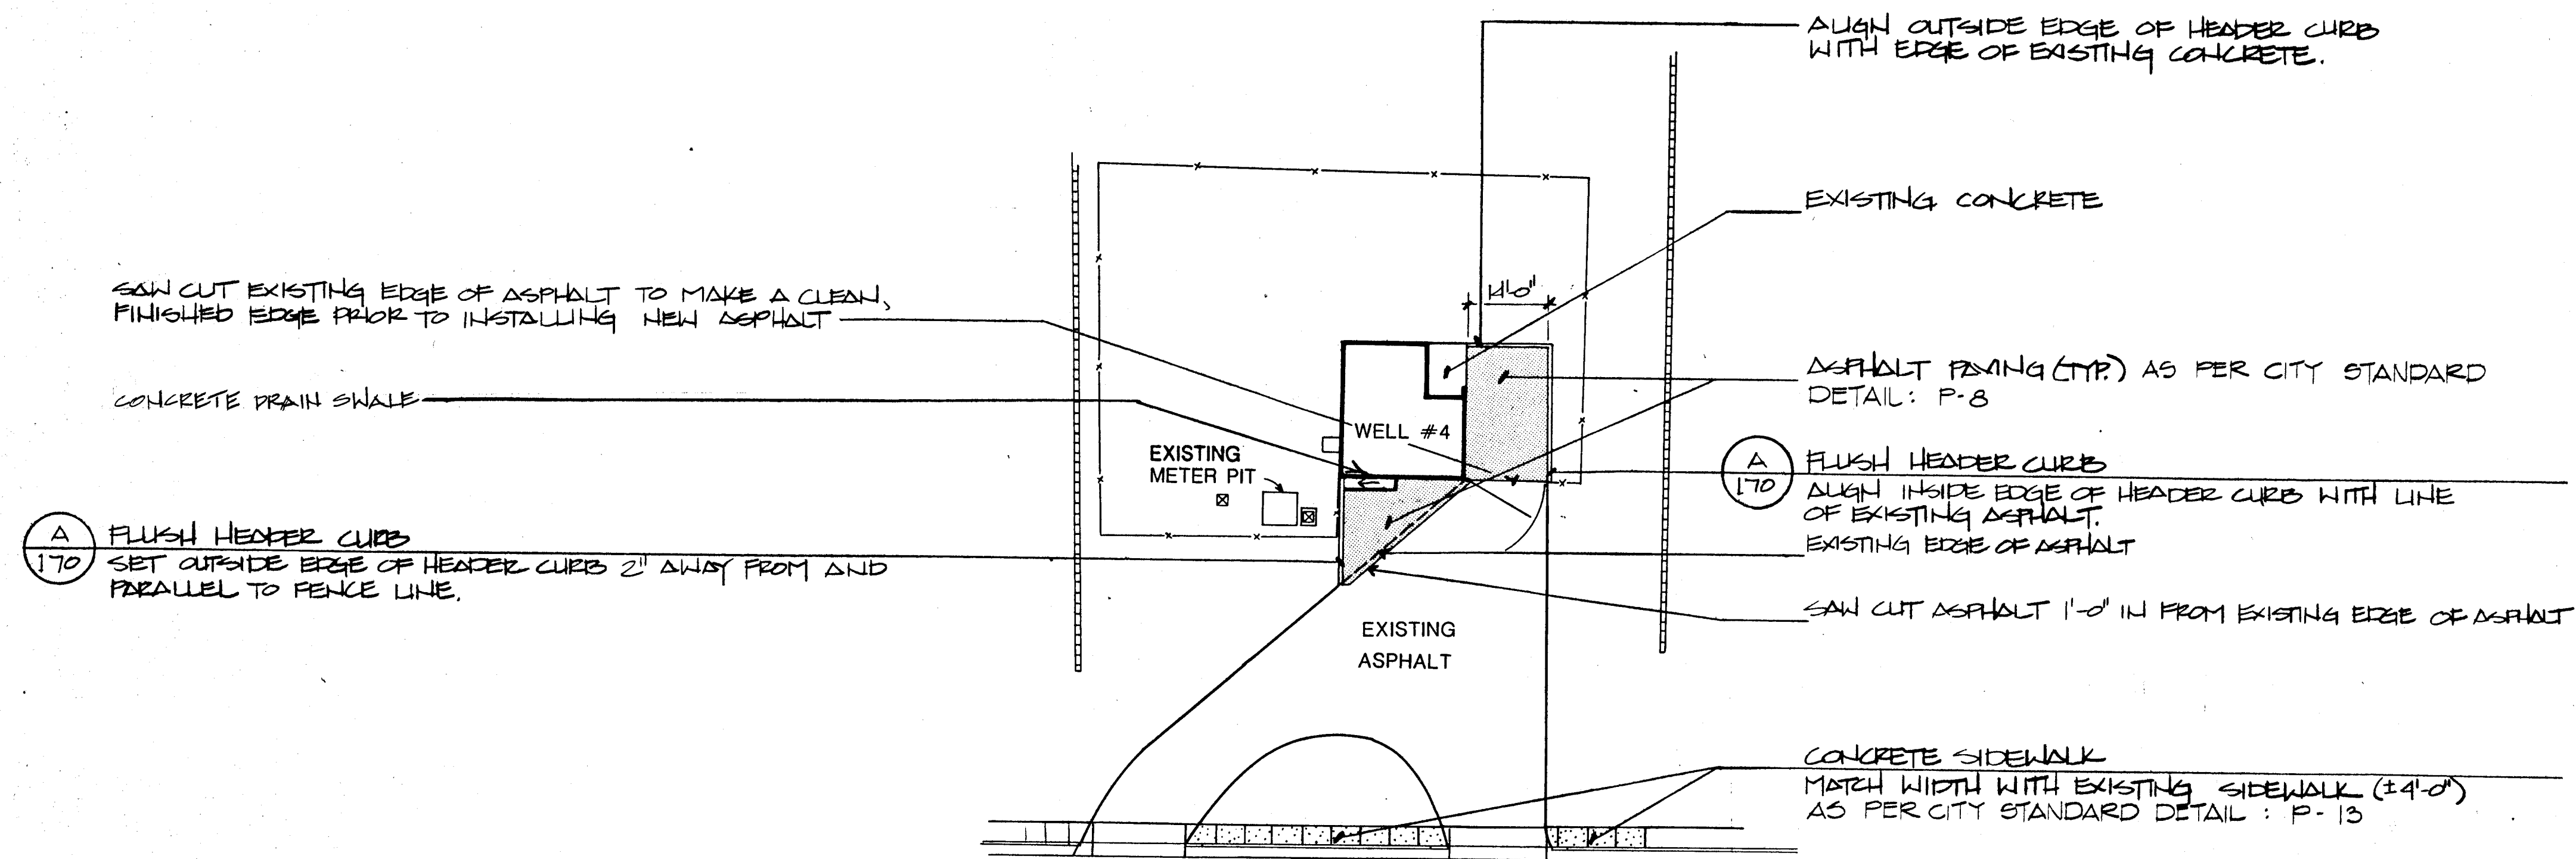


OSUNA NE

SCALE 1"=20'-0"

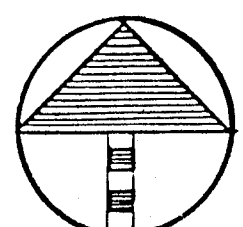

26 309711886

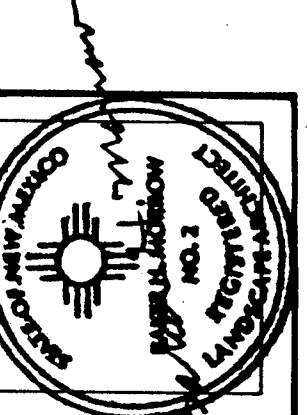

MORROW & COMPANY
LANDSCAPE ARCHITECTS
210 La Veta Drive NE
Albuquerque, New Mexico 87108
505-268-2266



NOVEMBER
1986



AS BUILT

THOMAS WELL #4
8729 OSUNA NE

CONSTRUCTION PLAN

LANDSCAPING IMPROVEMENTS FOR
WATER SYSTEM FACILITY SITES
WATER SYSTEMS DIVISION
CITY OF ALBUQUERQUE
ALBUQUERQUE, NEW MEXICO

SHEET
13
10
12

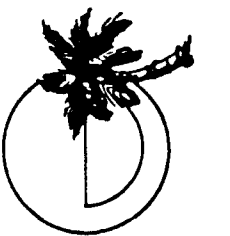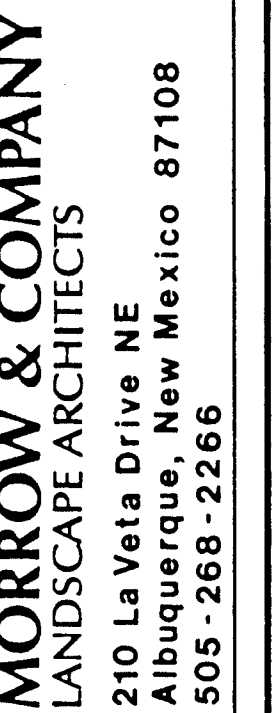
NOVEMBER
1986

AS BUILT


THOMAS WELL #4
8729 OSUNA NE
IRRIGATION PLAN

LANDSCAPING IMPROVEMENTS FOR
WATER SYSTEM FACILITY SITES
WATER SYSTEMS DIVISION
CITY OF ALBUQUERQUE
ALBUQUERQUE, NEW MEXICO


SHEET
140
OF
172

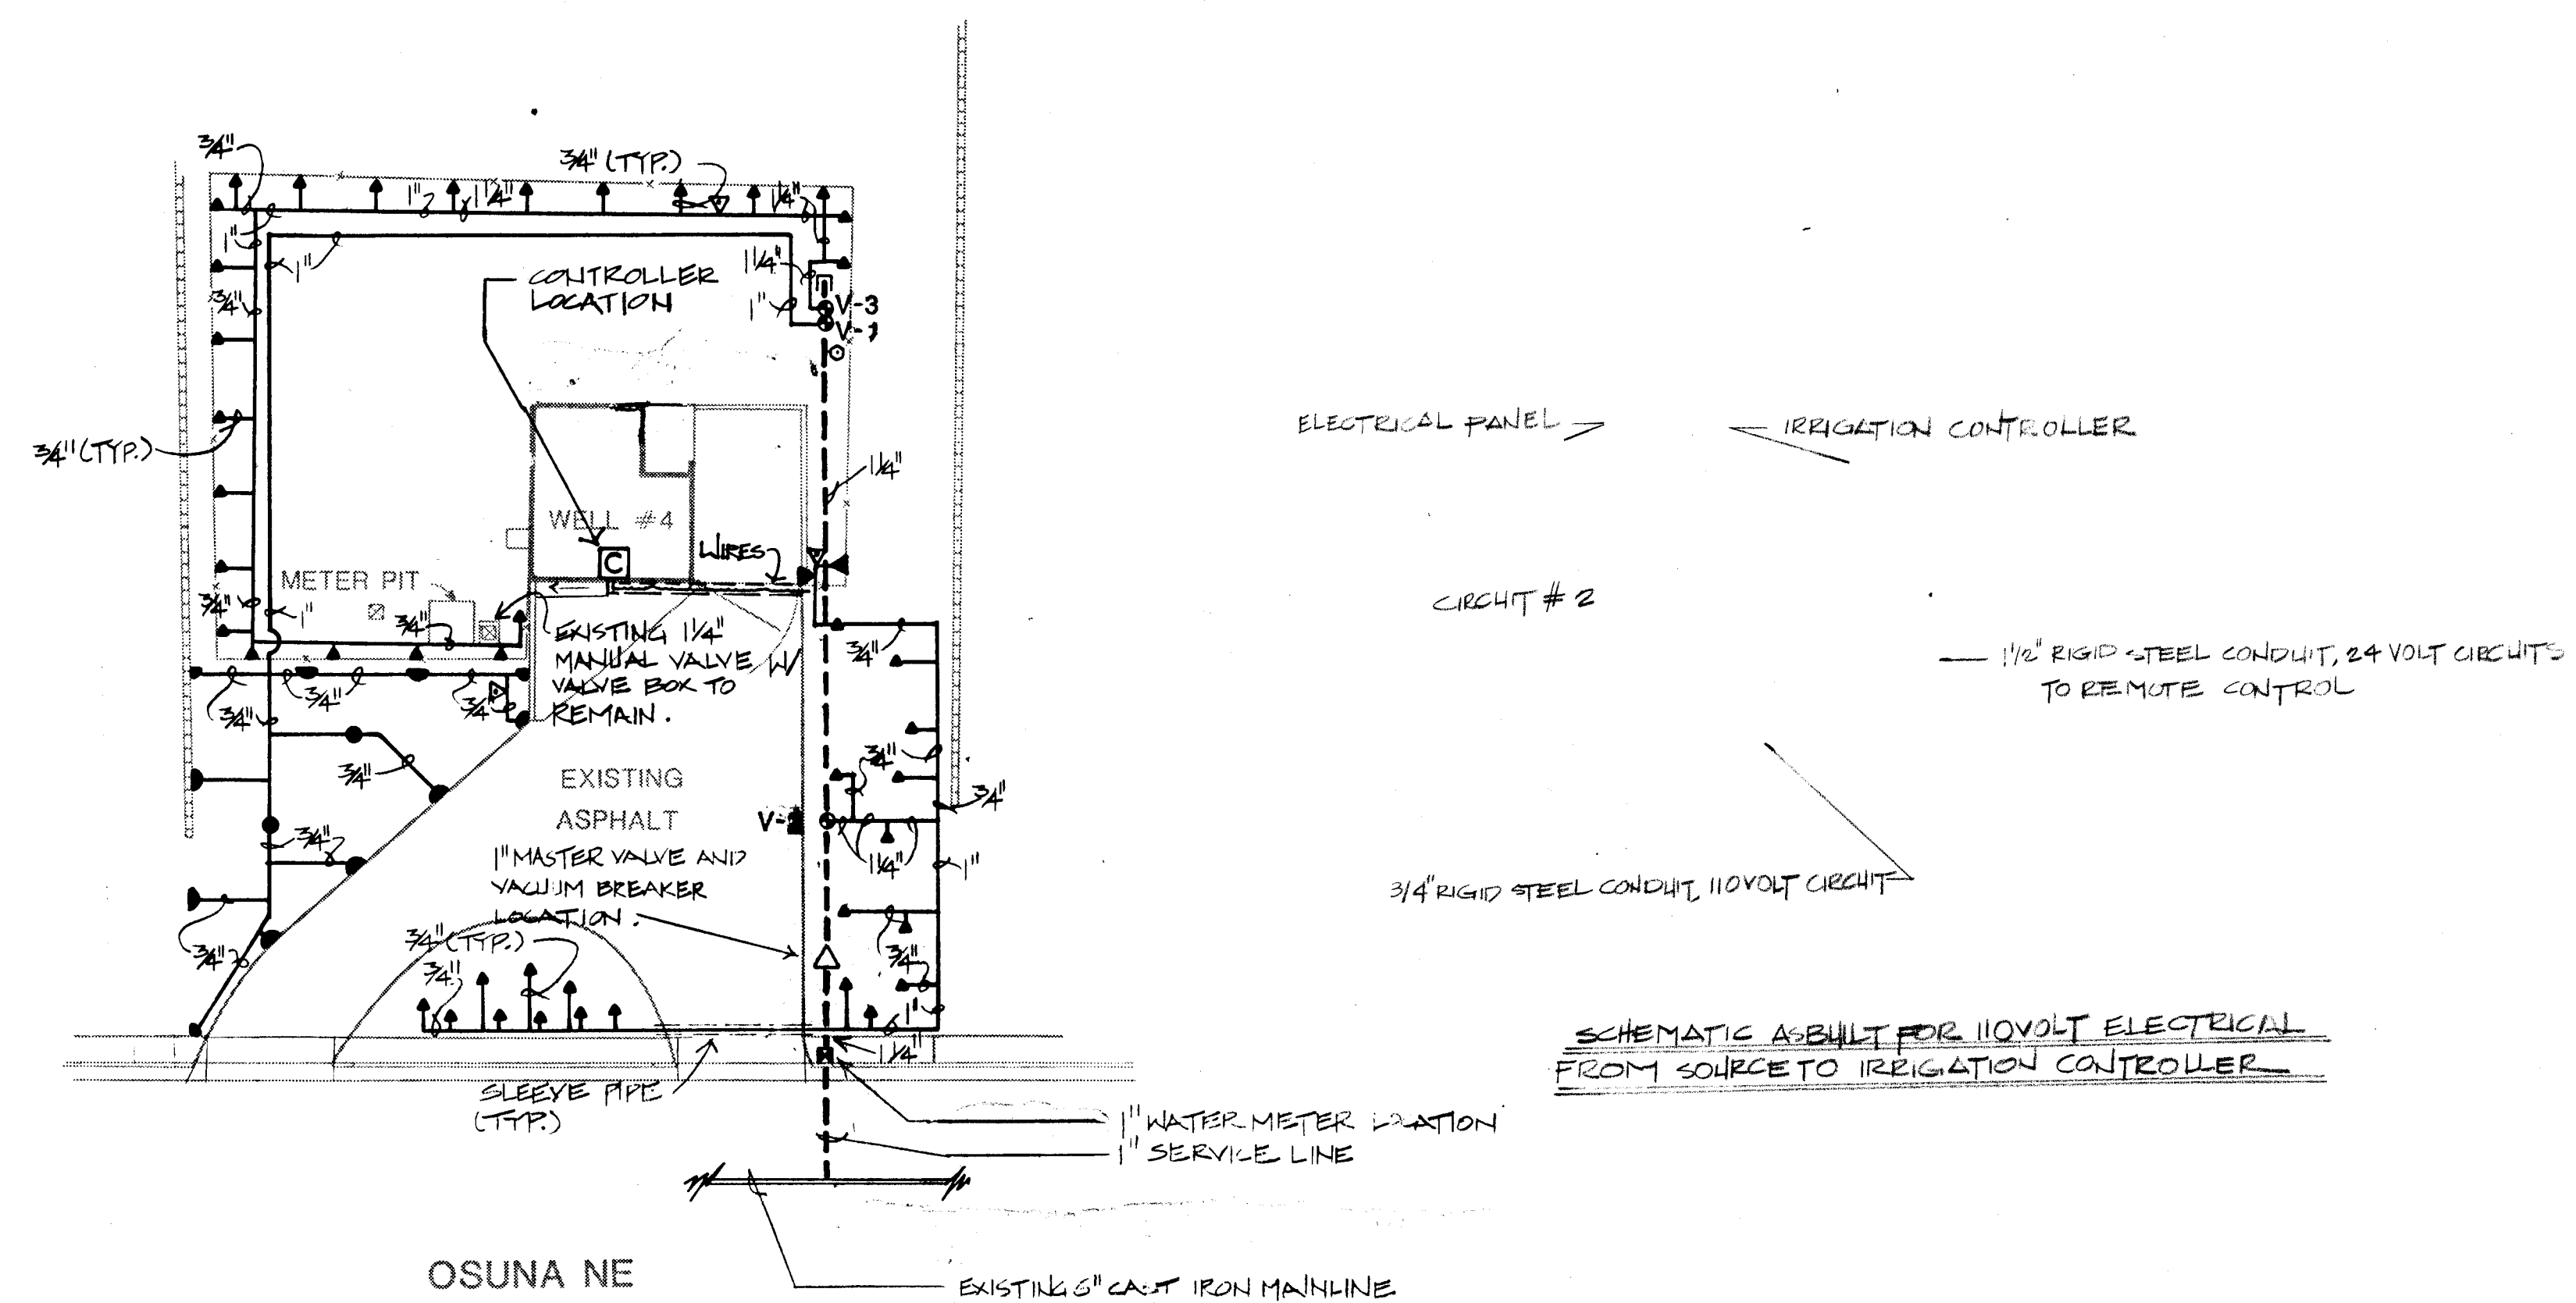

SCALE 1"=20'-0"

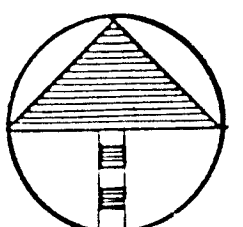


26 309.711986

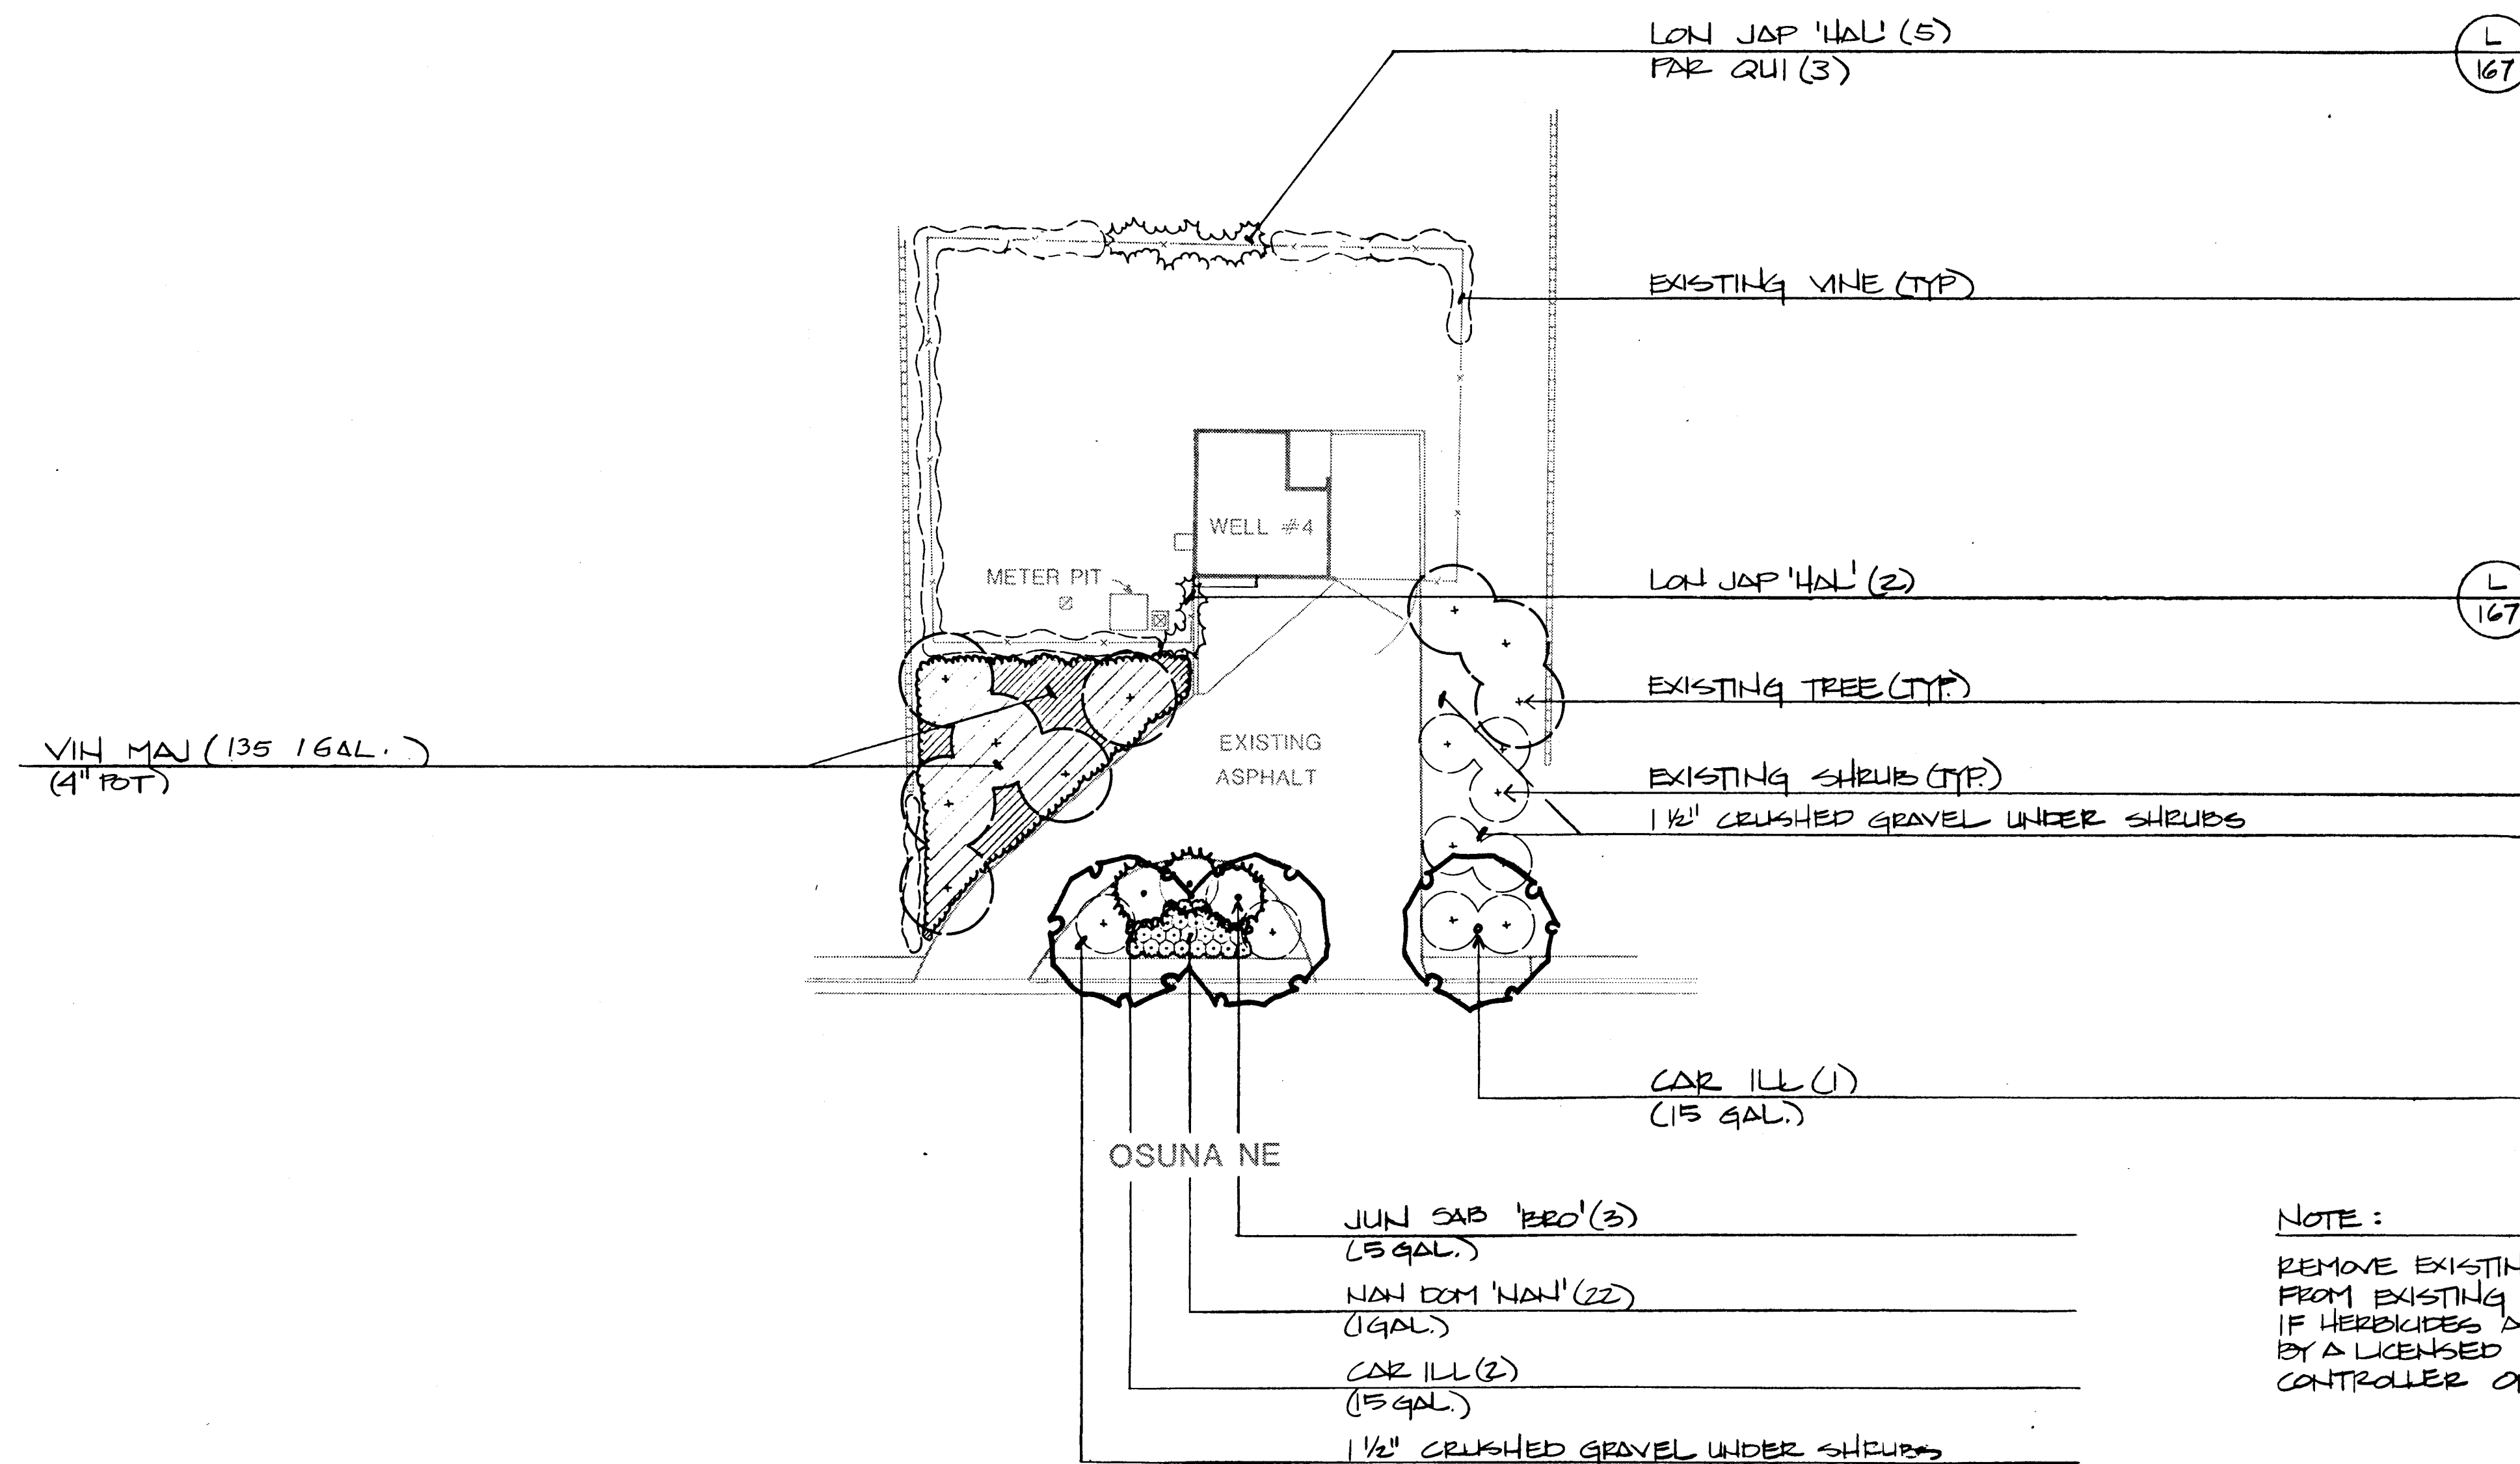

SCALE 1"=20'-0"


0 10 20 40

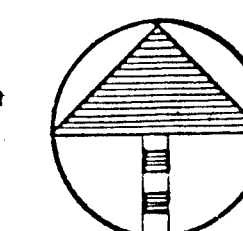

26 309712086



MORROW & COMPANY
LANDSCAPE ARCHITECTS
210 La Veta Drive NE
Albuquerque, New Mexico 87108
505-268-2266

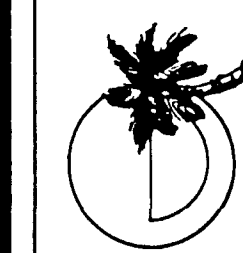


NOVEMBER
1986

AS BUILT

THOMAS WELL #4
8729 OSUNA NE
PLANTING PLAN

LANDSCAPING IMPROVEMENTS FOR
WATER SYSTEM FACILITY SITES
WATER SYSTEMS DIVISION
CITY OF ALBUQUERQUE
ALBUQUERQUE, NEW MEXICO


SHEET
14
172

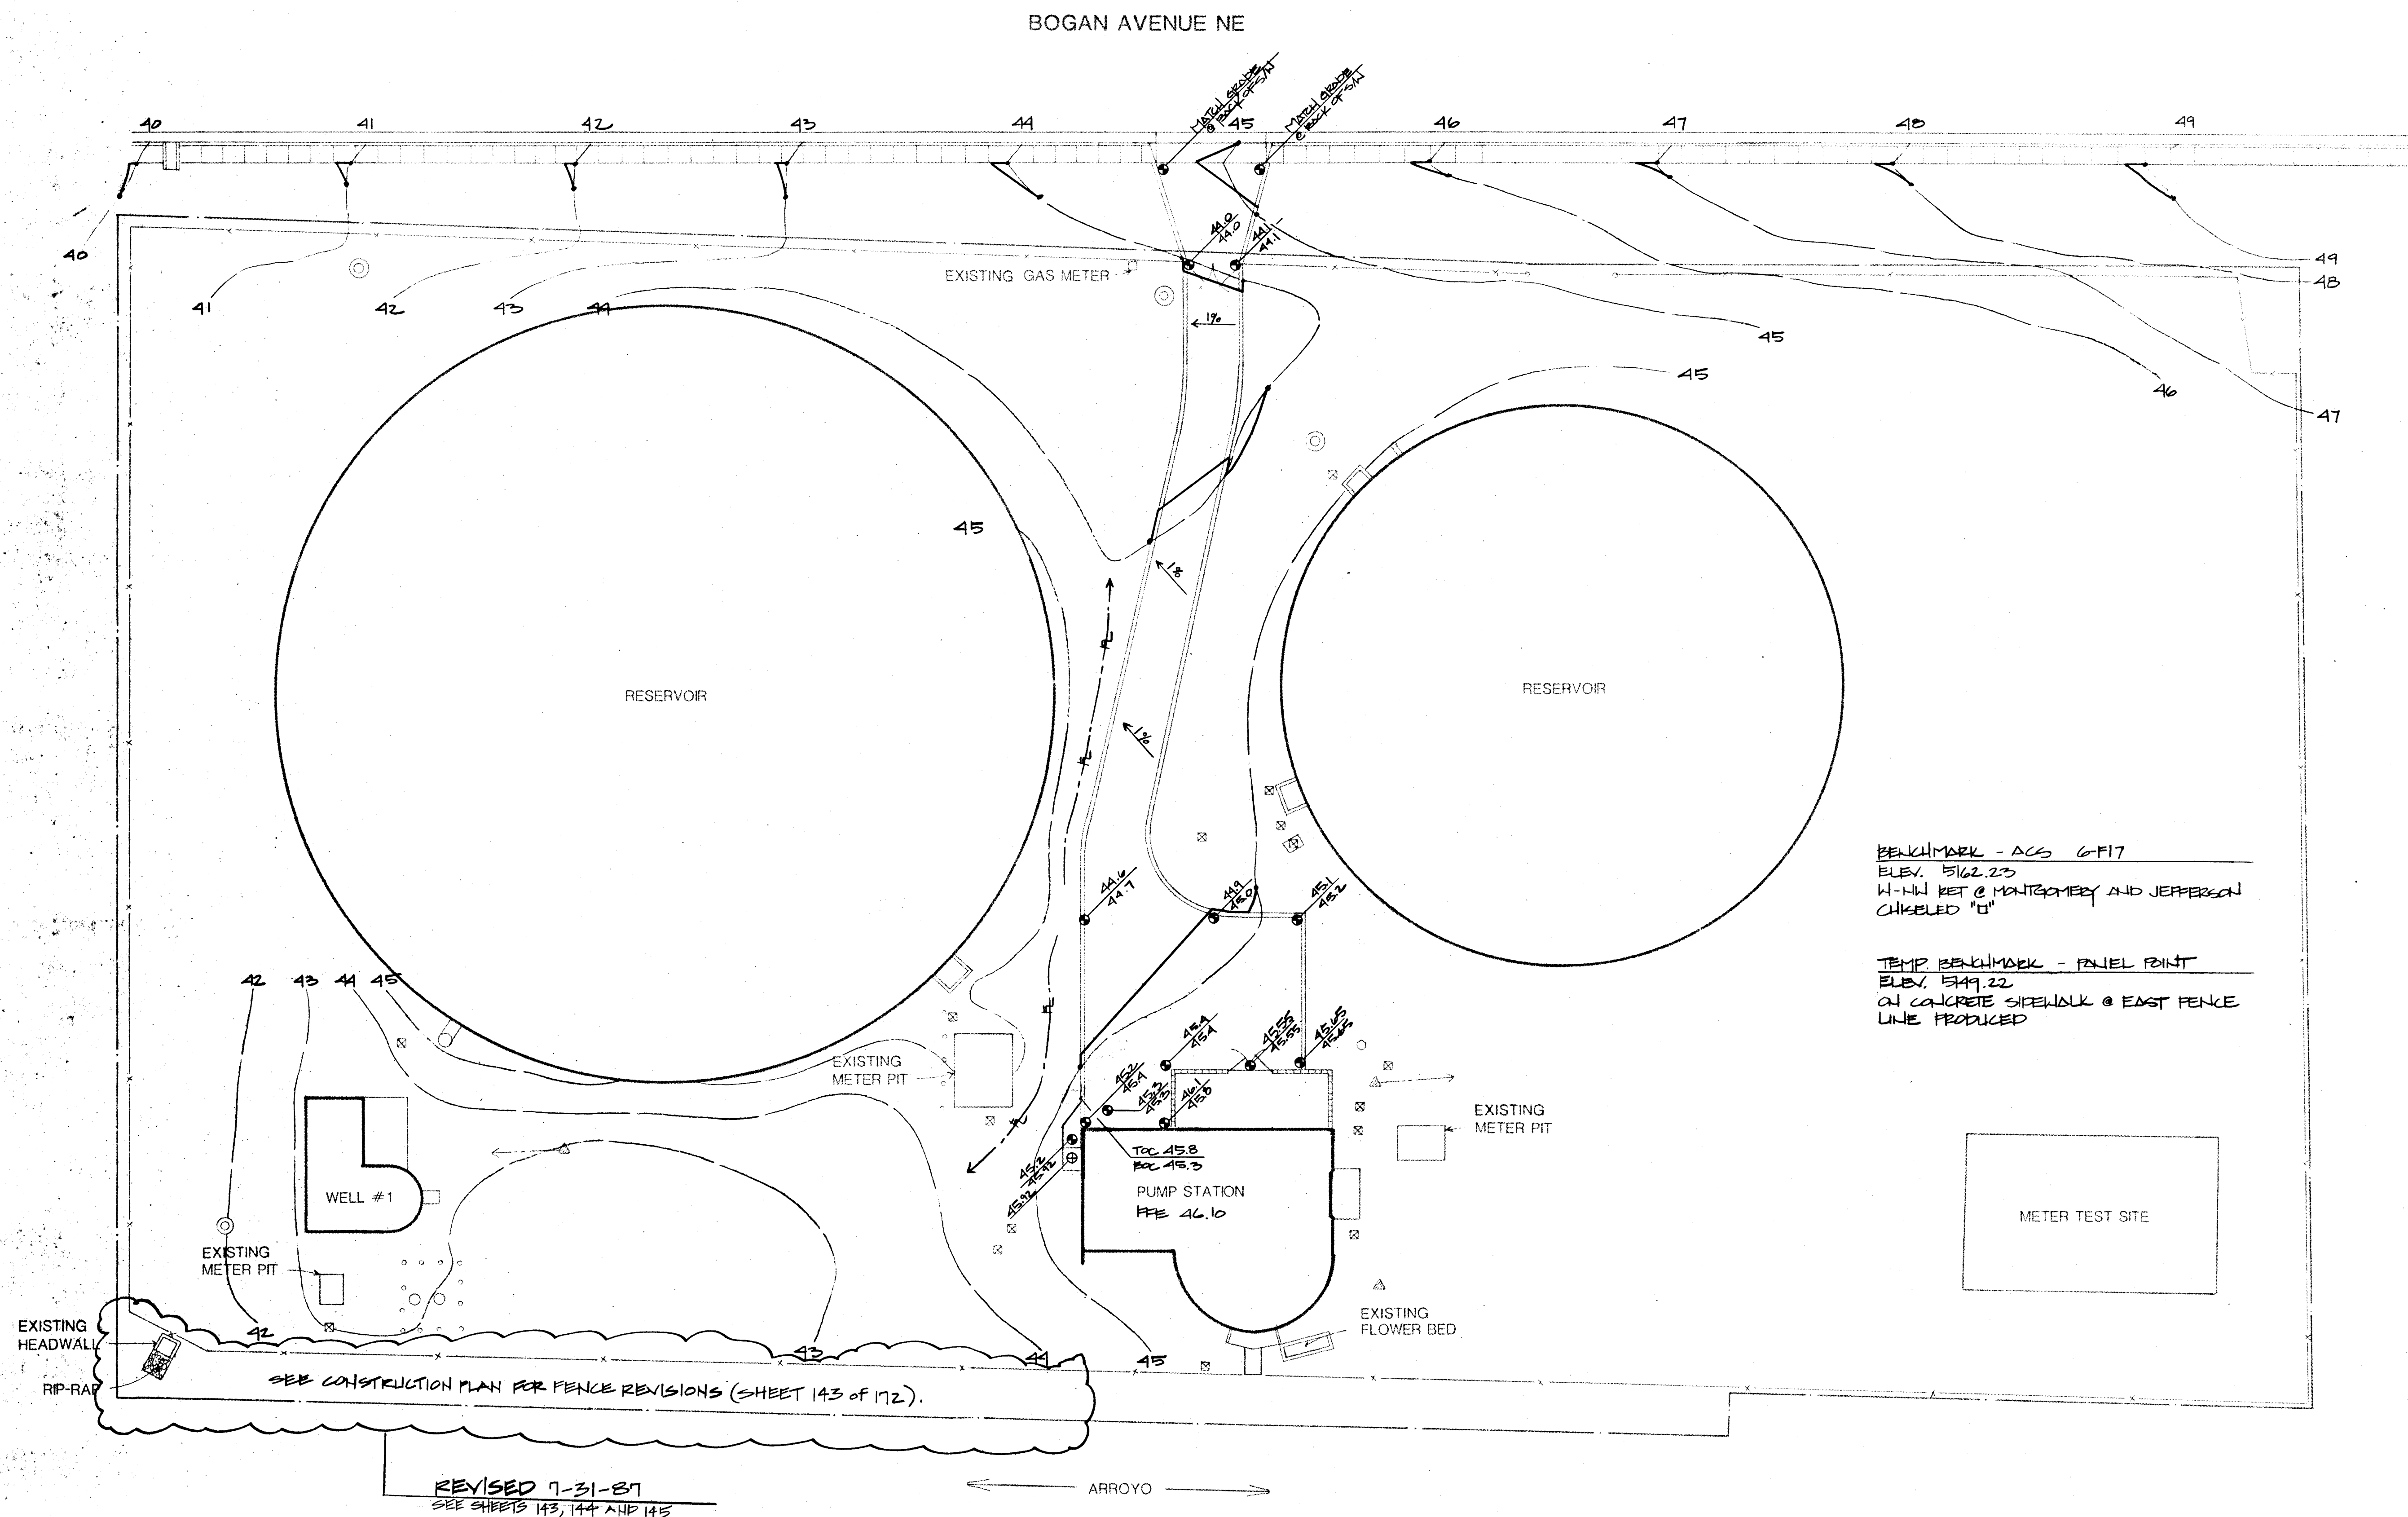

SCALE 1"=20'-0"

0 10 20 40

26 309712186

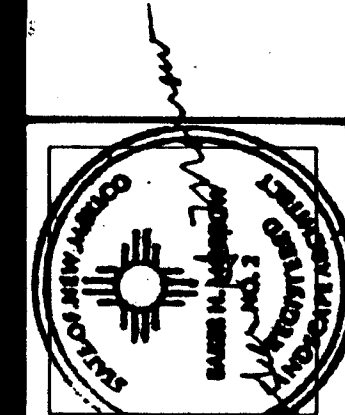

MORROW & COMPANY
LANDSCAPE ARCHITECTS
210 La Veta Drive NE
Albuquerque, New Mexico 87108
505-268-2266




NOVEMBER
1986

AS BUILT

VOL-ANDIA WELL #1, RESERVOIR #1 & #2 &
PUMP STATION
4300 BOGAN AVENUE NE
GRADING PLAN

LANDSCAPING IMPROVEMENTS FOR
WATER SYSTEM FACILITY SITES
WATER SYSTEMS DIVISION
CITY OF ALBUQUERQUE
ALBUQUERQUE, NEW MEXICO

SHEET
143
172

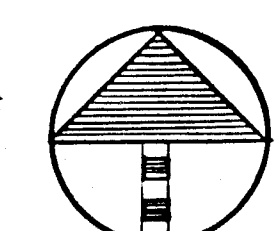

DEMOLISH EXISTING CURB AND GUTTER, AND SIDEWALK TO NEAREST EXPANSION OR CONTROL JOINT. REMOVE ASPHALT ±12' AS NEEDED TO CONSTRUCT NEW DRIVEPAD.

PROPOSED CONC. DRIVE PAD AS PER CITY STANDARD DETAIL: P-11

PROPOSED CONC. CURB & GUTTER AS PER CITY STANDARD DETAIL: P-8



PROPOSED CONC. SIDEWALK AS PER CITY STANDARD DETAIL: P-13

DEMOLISH EXISTING DRIVE PAD TO THE NEAREST EXPANSION OR CONTROL JOINT. REMOVE ASPHALT ±12' AS NEEDED TO CONSTRUCT NEW CURB AND GUTTER.

PROPOSED CONC. CURB & GUTTER AS PER CITY STANDARD DETAIL: P-8

PROPOSED 4'-0" CONCRETE SIDEWALK AS PER CITY STANDARD DETAIL: P-13

BOGAN AVENUE NE

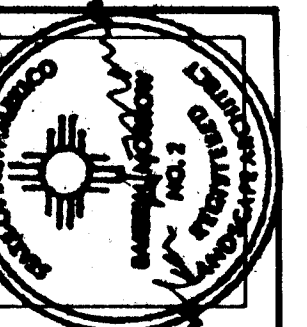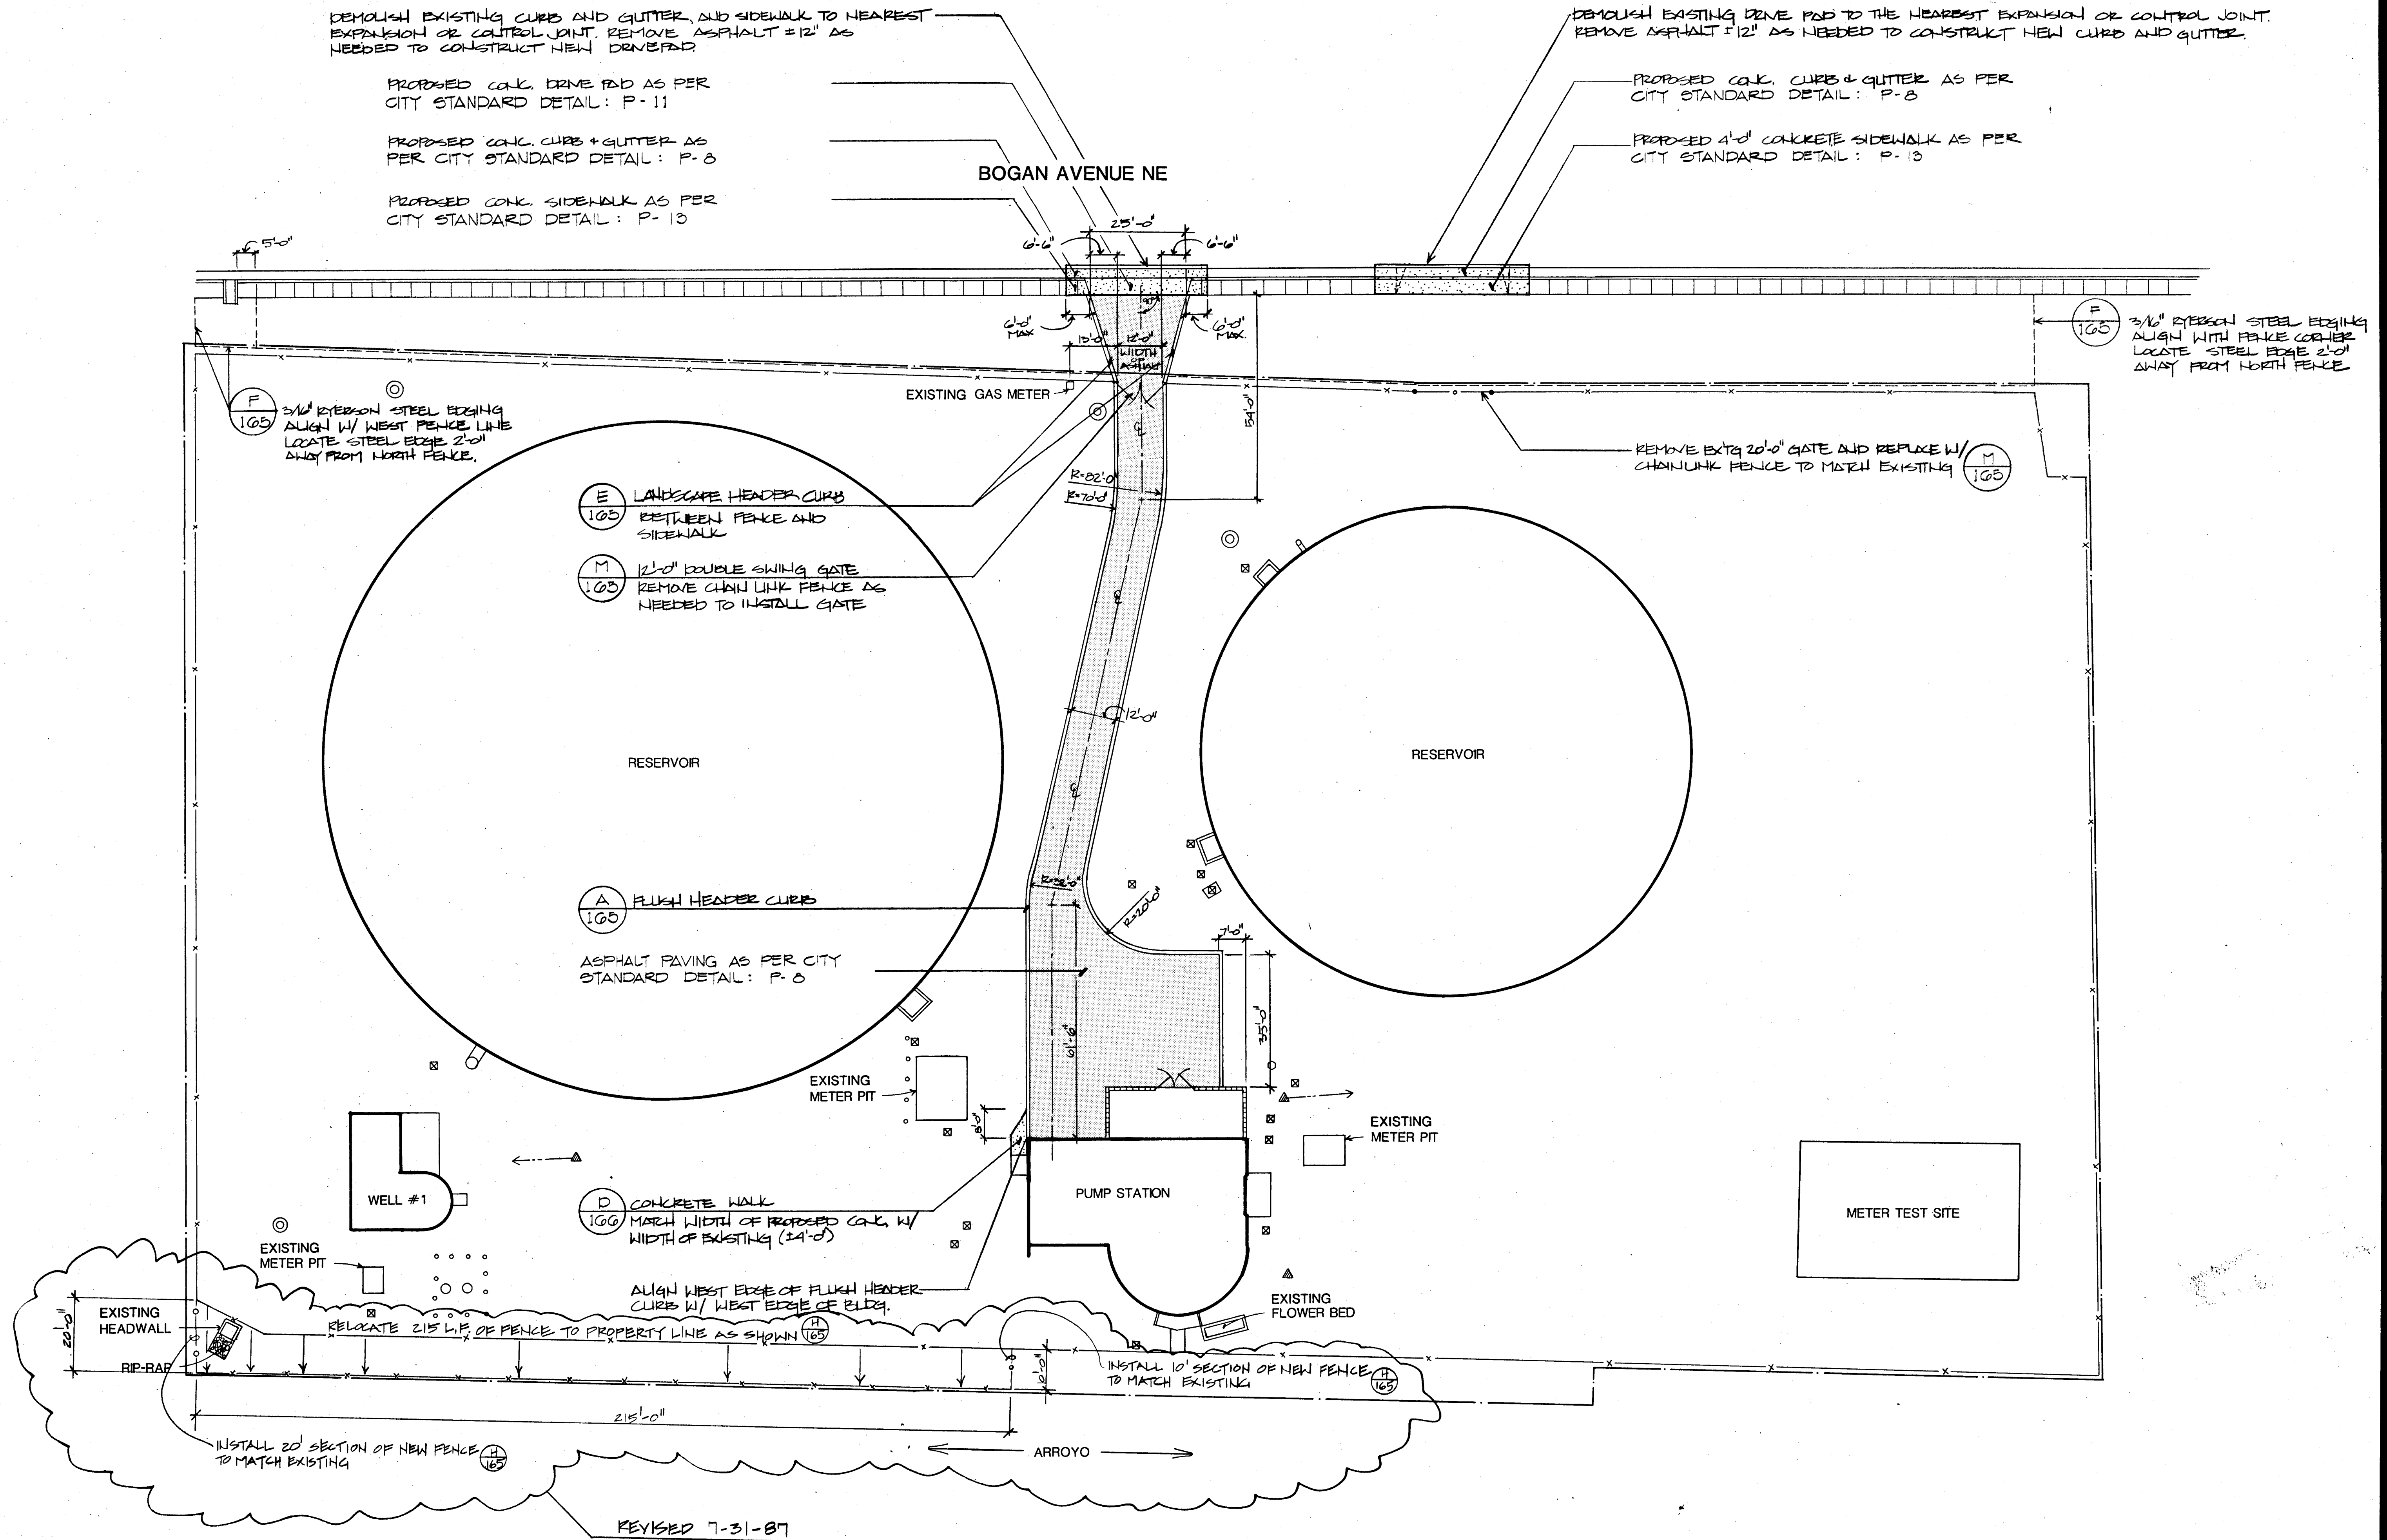

MORROW & COMPANY
LANDSCAPE ARCHITECTS
210 La Veta Drive NE
Albuquerque, New Mexico 87108
505-268-2266




 
NOVEMBER
1986

VOL-ANDIA WELL #1, RESERVOIR #1 & #2 & PUMP STATION
4300 BOGAN AVENUE NE
AS BUILT
CONSTRUCTION PLAN



LANDSCAPING IMPROVEMENTS FOR
WATER SYSTEM FACILITY SITES
WATER SYSTEMS DIVISION
CITY OF ALBUQUERQUE
ALBUQUERQUE, NEW MEXICO

SHEET
143
07
112


SCALE 1"=20'-0"

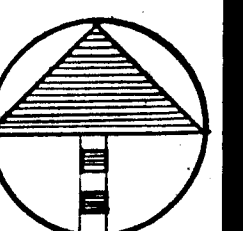

26 309712286

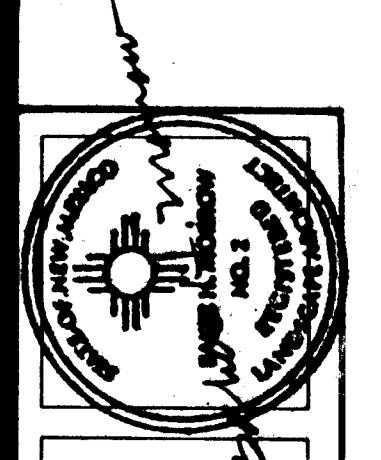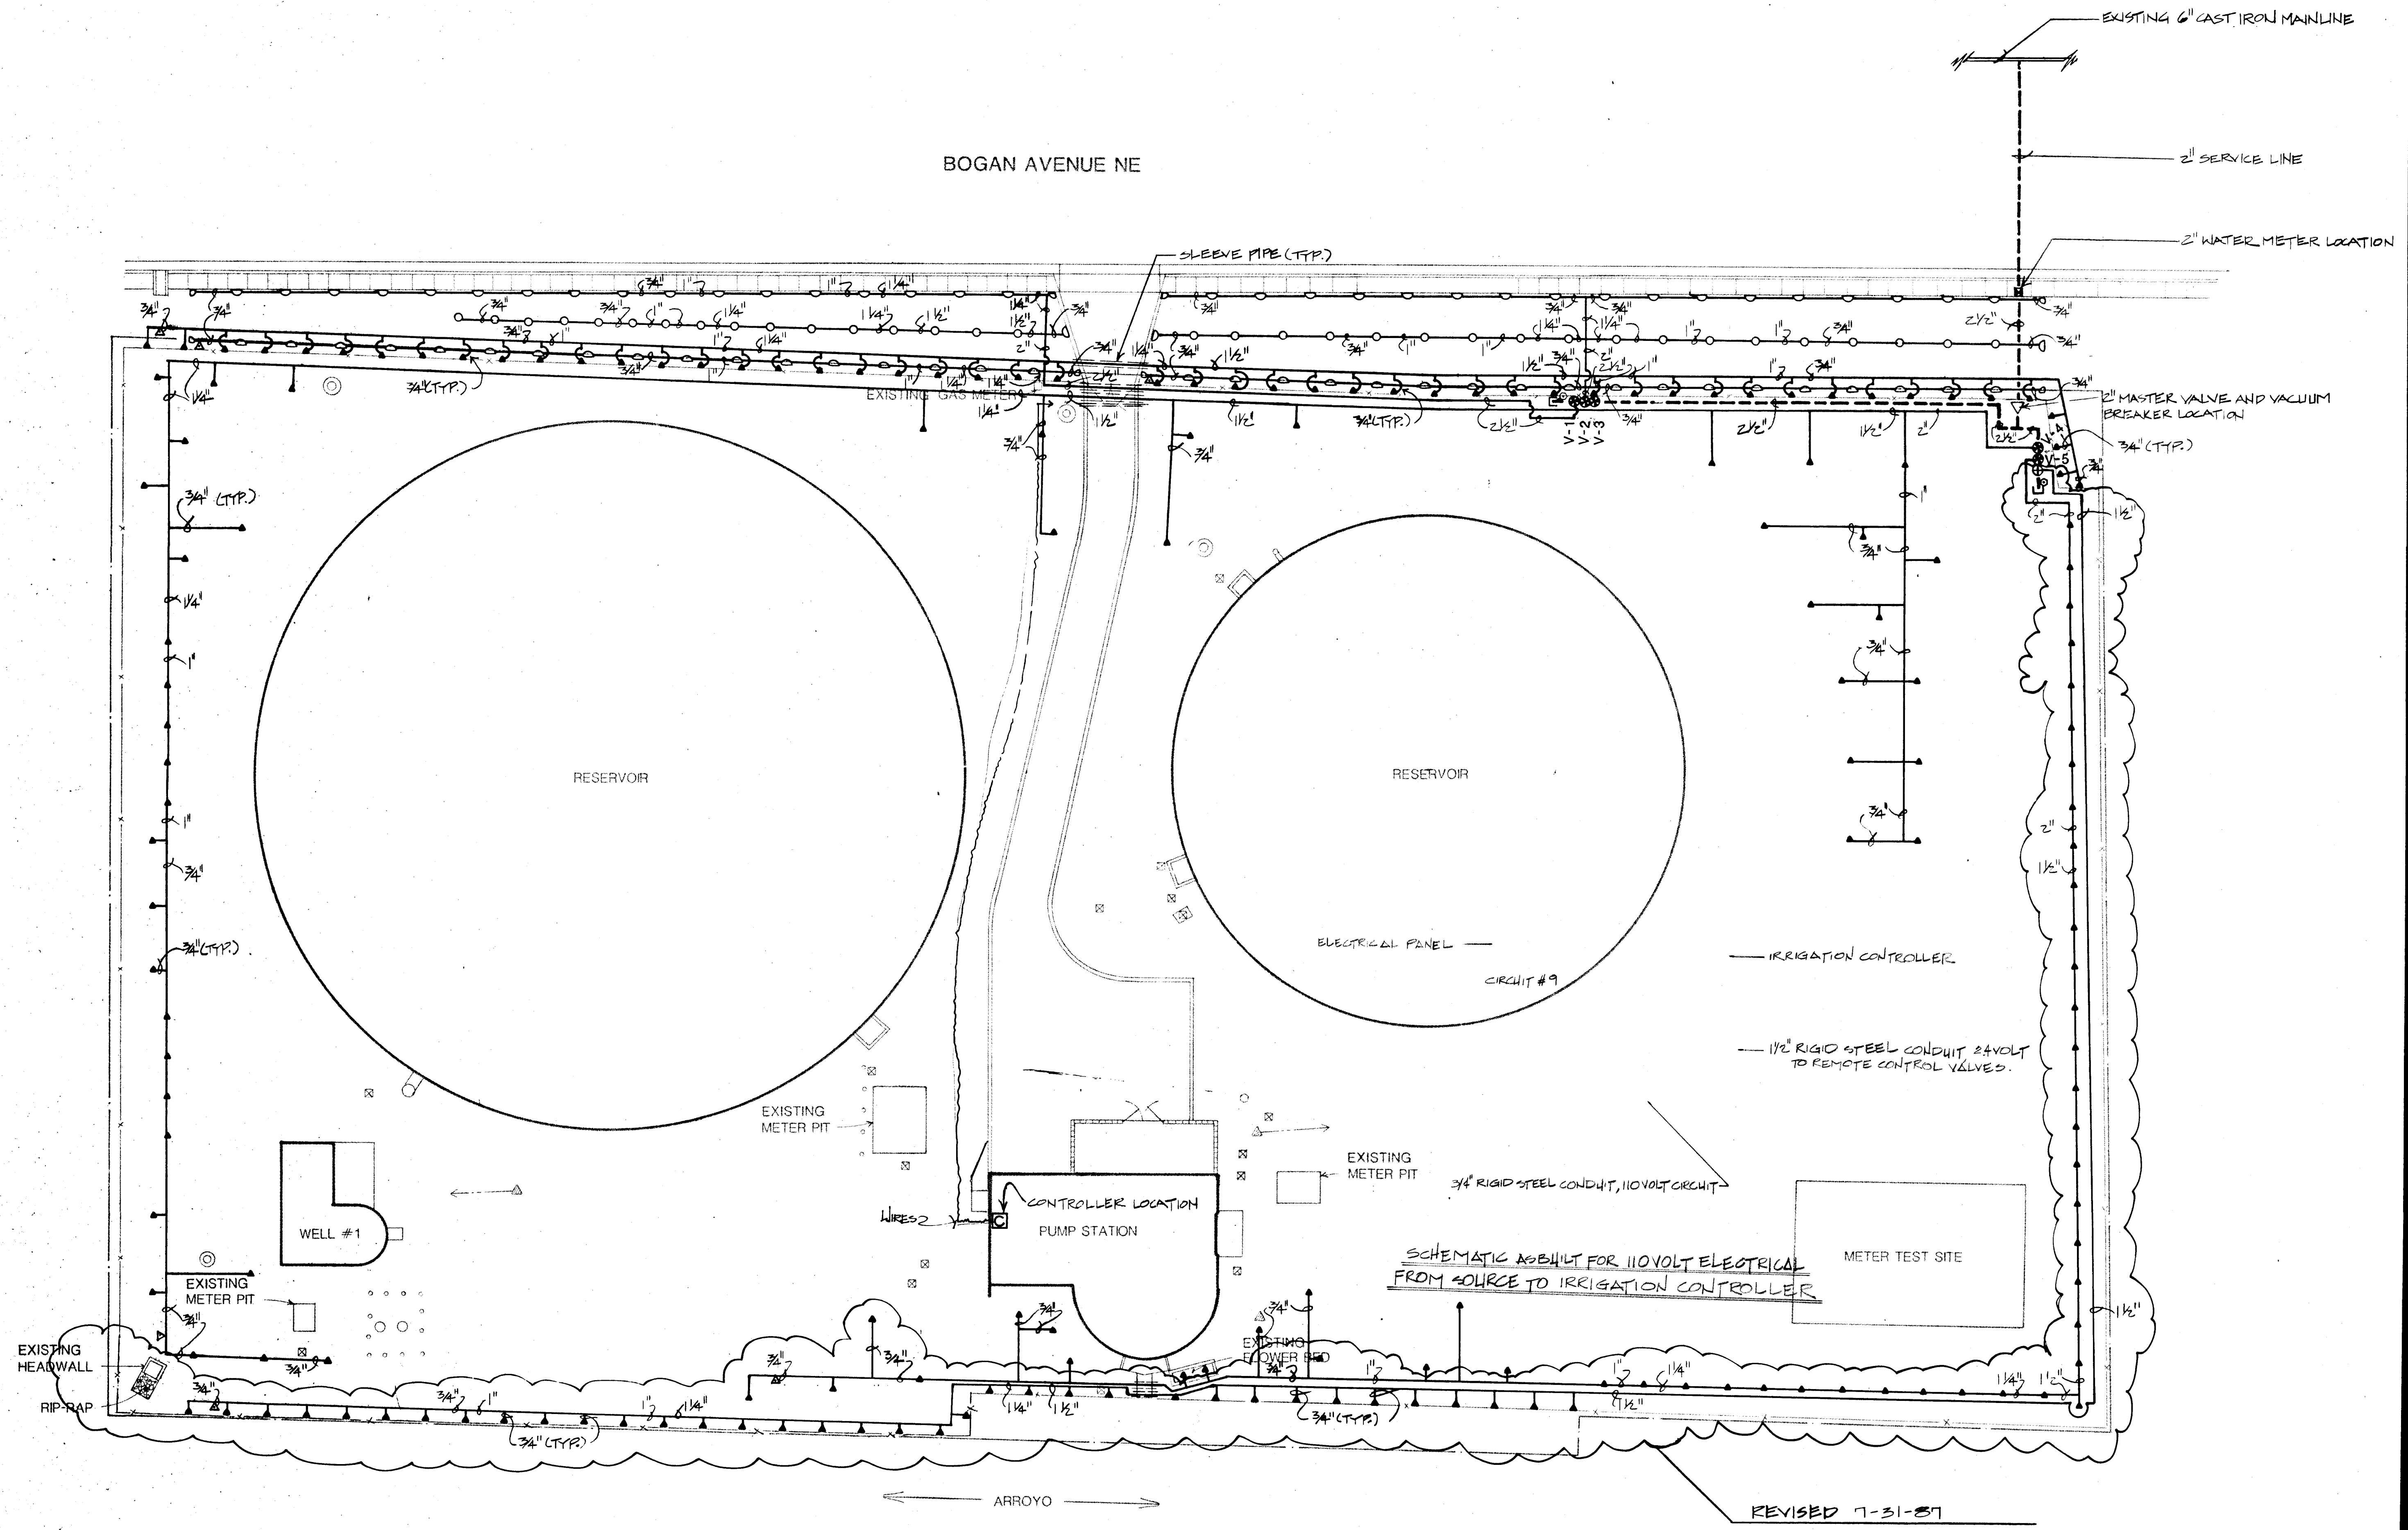

MORROW & COMPANY
 LANDSCAPE ARCHITECTS
 210 La Veta Drive NE
 Albuquerque, New Mexico 87108
 505-268-2266

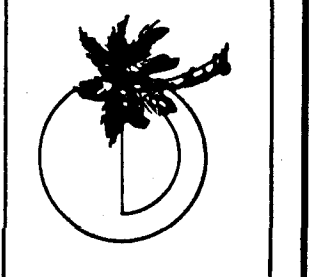

NOVEMBER
 1986


VOL-ANDIA WELL #1, RESERVOIR #1 & #2 &
 PUMP STATION
 4300 BOGAN AVENUE NE
 IRRIGATION PLAN

AS BUILT


LANDSCAPING IMPROVEMENTS FOR
 WATER SYSTEM FACILITY SITES
 WATER SYSTEMS DIVISION
 CITY OF ALBUQUERQUE
 ALBUQUERQUE, NEW MEXICO

SHEET
 144
 172

SCALE 1"=20'-0"
 0 10 20 40

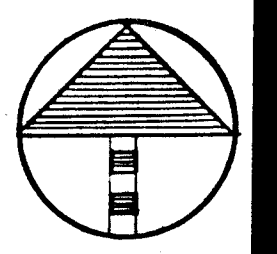

26 309712386

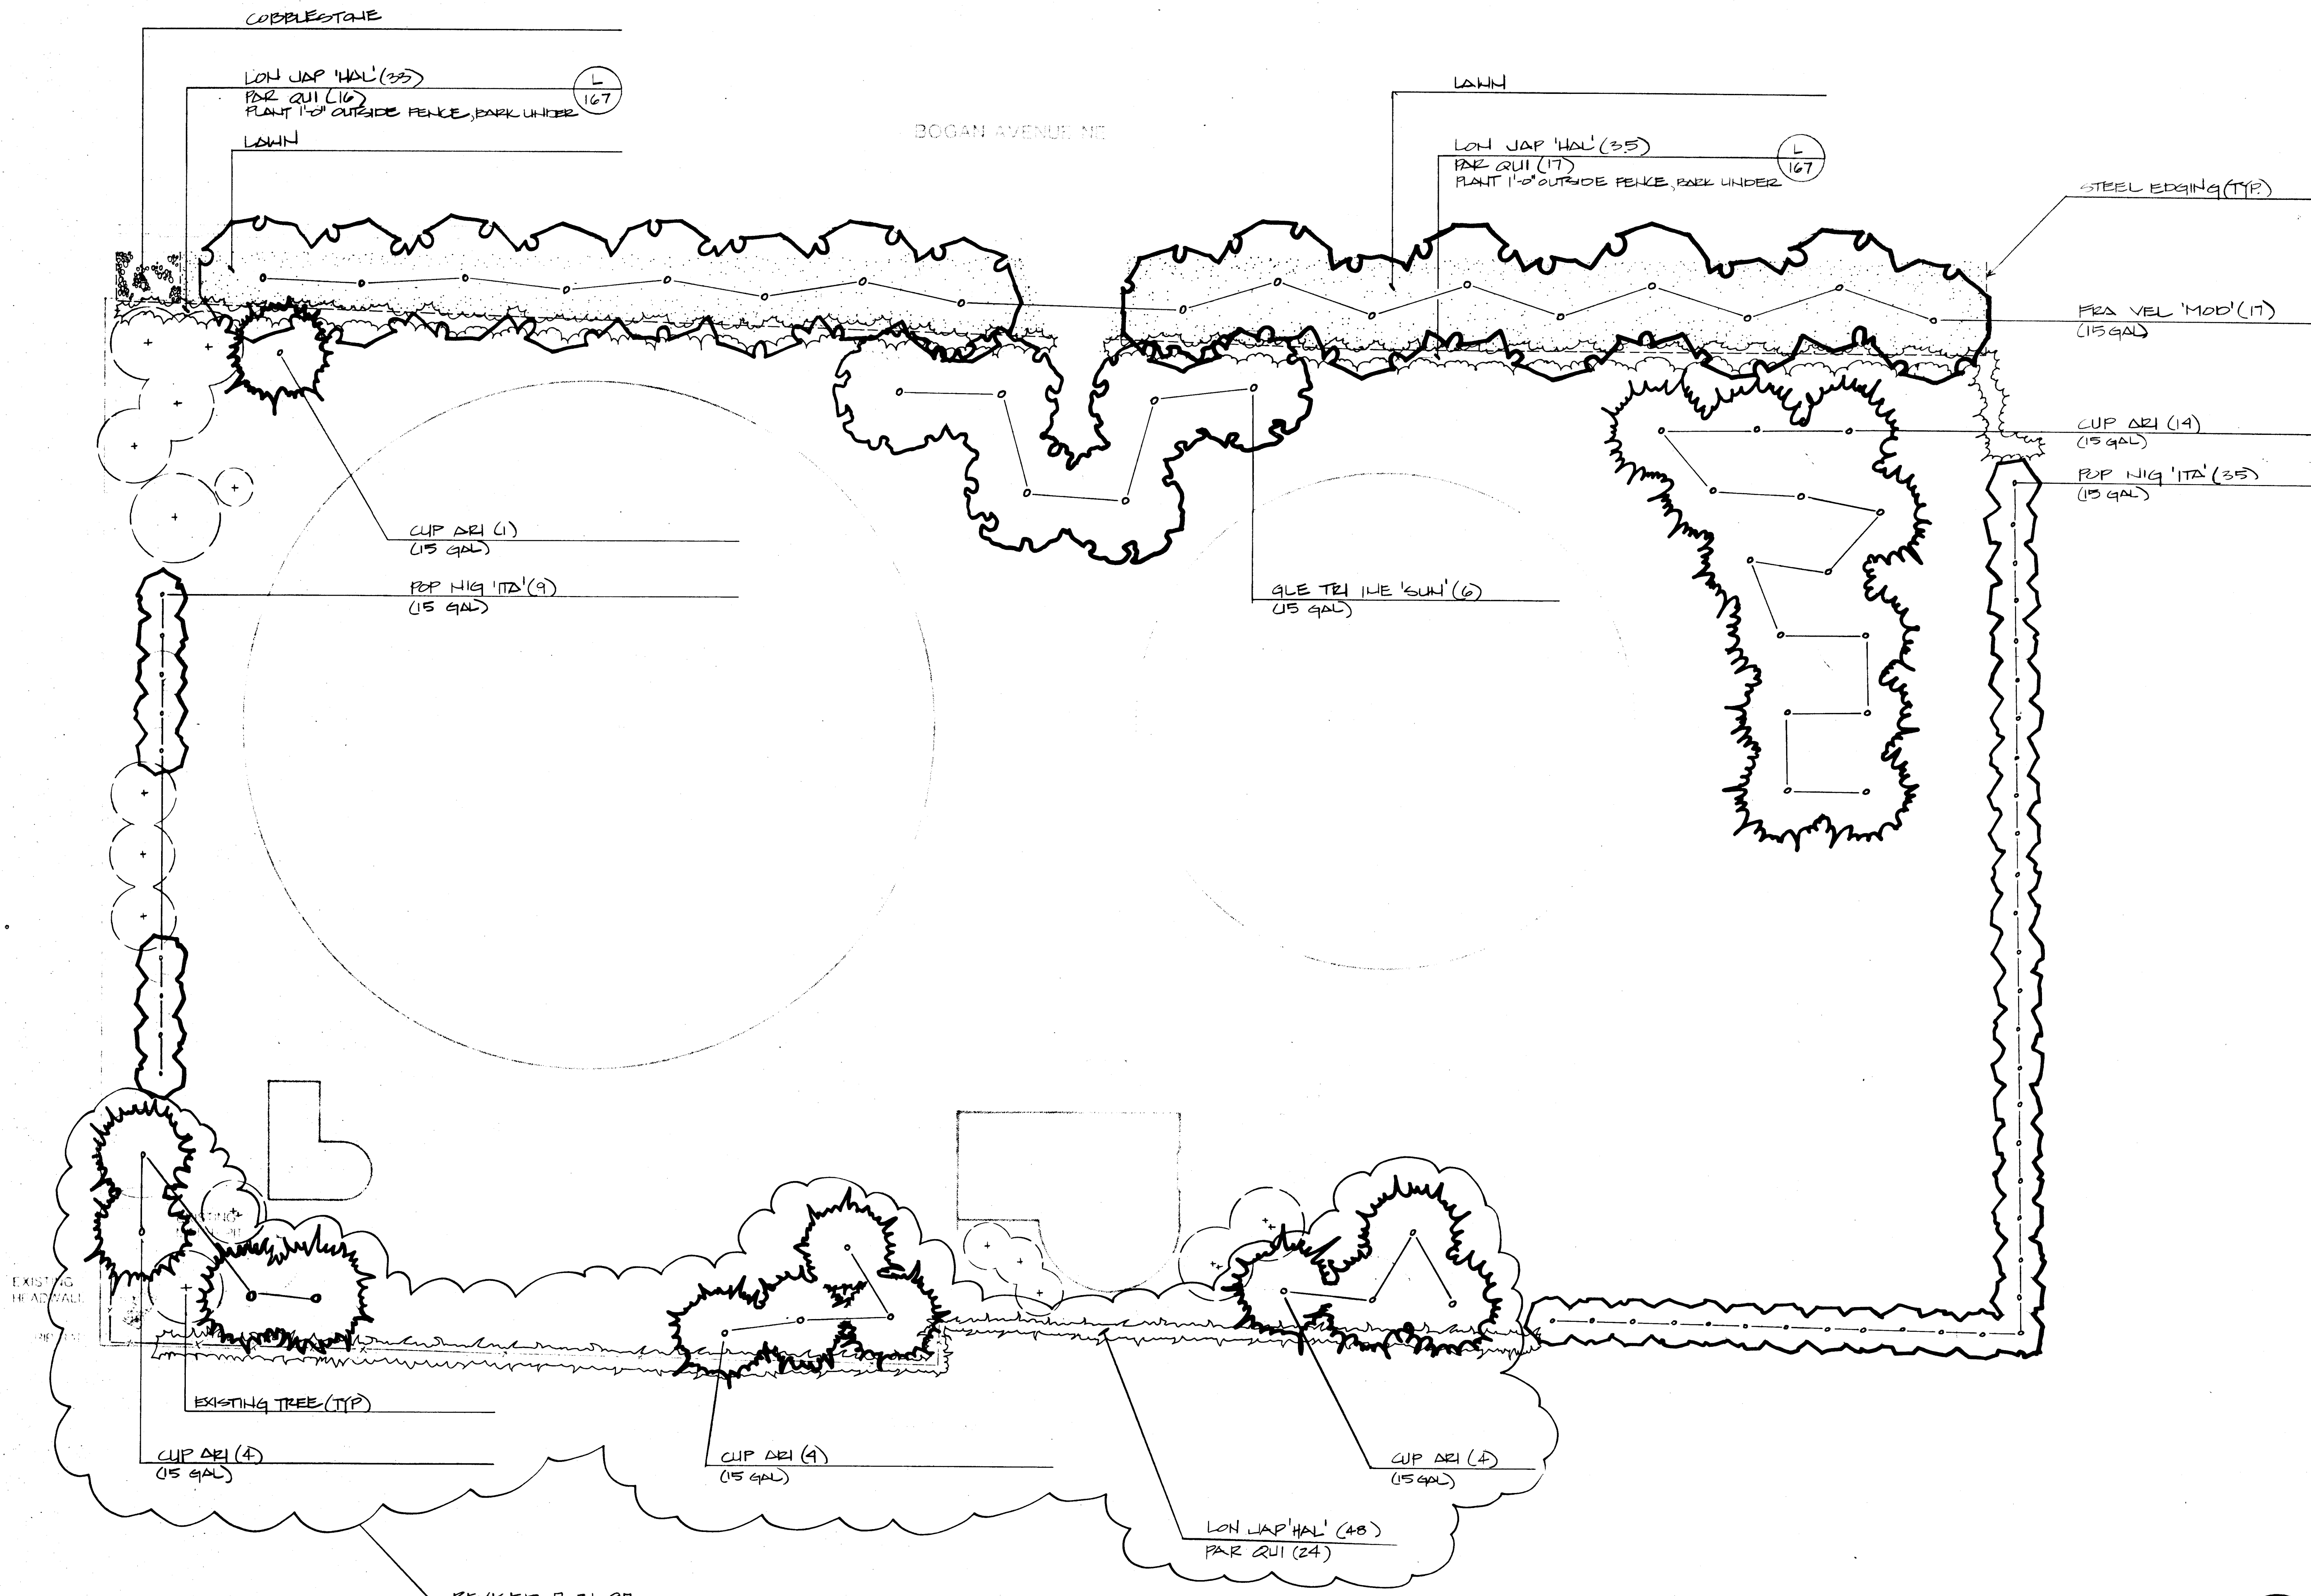

COBBLESTONE

LON JAP 'HAL' (35)

PAR QUI (16)

PLANT 1'-0" OUTSIDE FENCE, BARK UNDER

LAWN

BOGAN AVENUE NE

LAWN

LON JAP 'HAL' (35)

PAR QUI (17)

PLANT 1'-0" OUTSIDE FENCE, BARK UNDER

STEEL EDGING (TYP)

FRA VEL 'MOD' (17)
(15 GAL)

CUP ARI (14)
(15 GAL)

POP NIG 'ITA' (35)
(15 GAL)

CUP ARI (1)
(15 GAL)

POP NIG 'ITA' (9)
(15 GAL)

GLE TRI ITE 'SUN' (6)
(15 GAL)

EXISTING TREE (TYP)

CUP ARI (4)
(15 GAL)



CUP ARI (4)
(15 GAL)

CUP ARI (4)
(15 GAL)

LON JAP 'HAL' (48)
PAR QUI (24)

REVISED 7-31-07

SCALE 1"=20'-0"
0 10 20 40

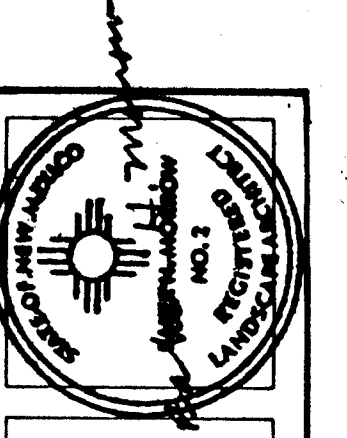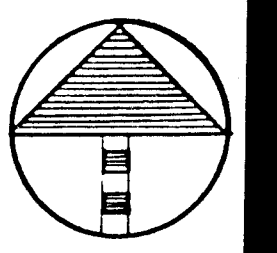

MORROW & COMPANY
LANDSCAPE ARCHITECTS
210 La Veta Drive NE
Albuquerque, New Mexico 87108
505-268-2266

NOVEMBER
1986


VOL-ANDIA WELL #1, RESERVOIR #1 & #2 &
PUMP STATION
4300 BOGAN AVENUE NE
PLANTING PLAN
AS BUILT

LANDSCAPING IMPROVEMENTS FOR
WATER SYSTEM FACILITY SITES
WATER SYSTEMS DIVISION
CITY OF ALBUQUERQUE
ALBUQUERQUE, NEW MEXICO

SHEET
145
12



26 309712986

MONTGOMERY PARK

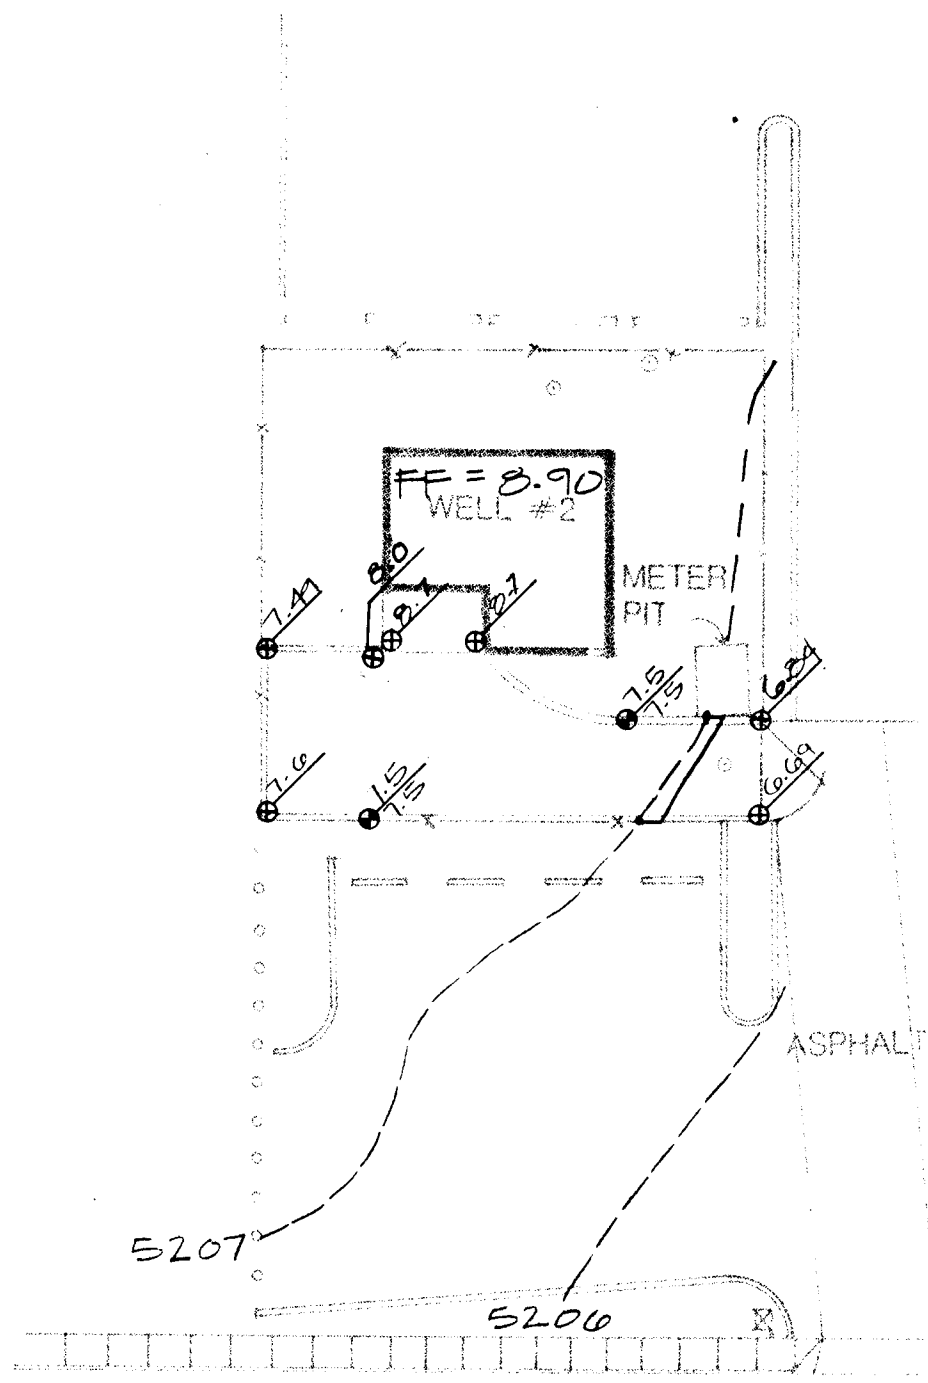

BM = 5205.71
(CUT IN @ TC)

PONDEROSA AVENUE NE

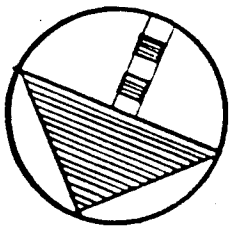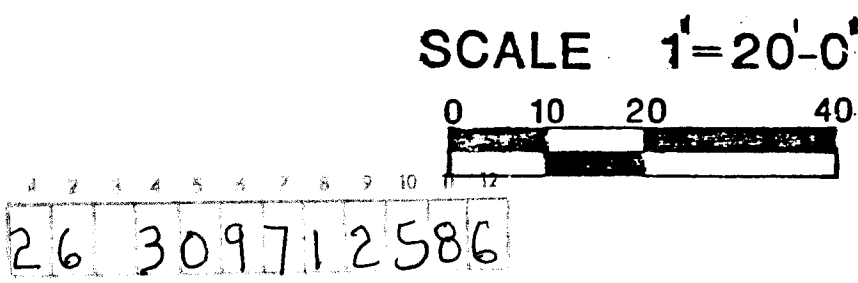


SHEET
18
2

LANDSCAPING IMPROVEMENTS FOR
WATER SYSTEM FACILITY SITES
WATER SYSTEMS DIVISION
CITY OF ALBUQUERQUE
ALBUQUERQUE, NEW MEXICO


VOL-ANDIA WELL #2
5212 PONDEROSA AVENUE NE
GRADING PLAN


AS BUILT

NOVEMBER
1986

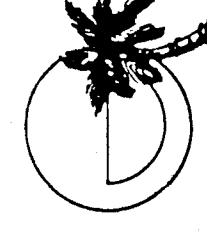

MORROW & COMPANY
LANDSCAPE ARCHITECTS
210 La Veta Drive NE
Albuquerque, New Mexico 87108
505-268-2266


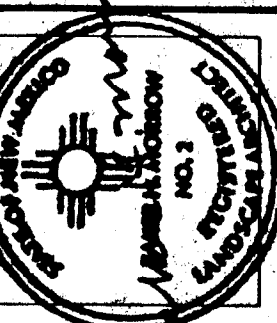


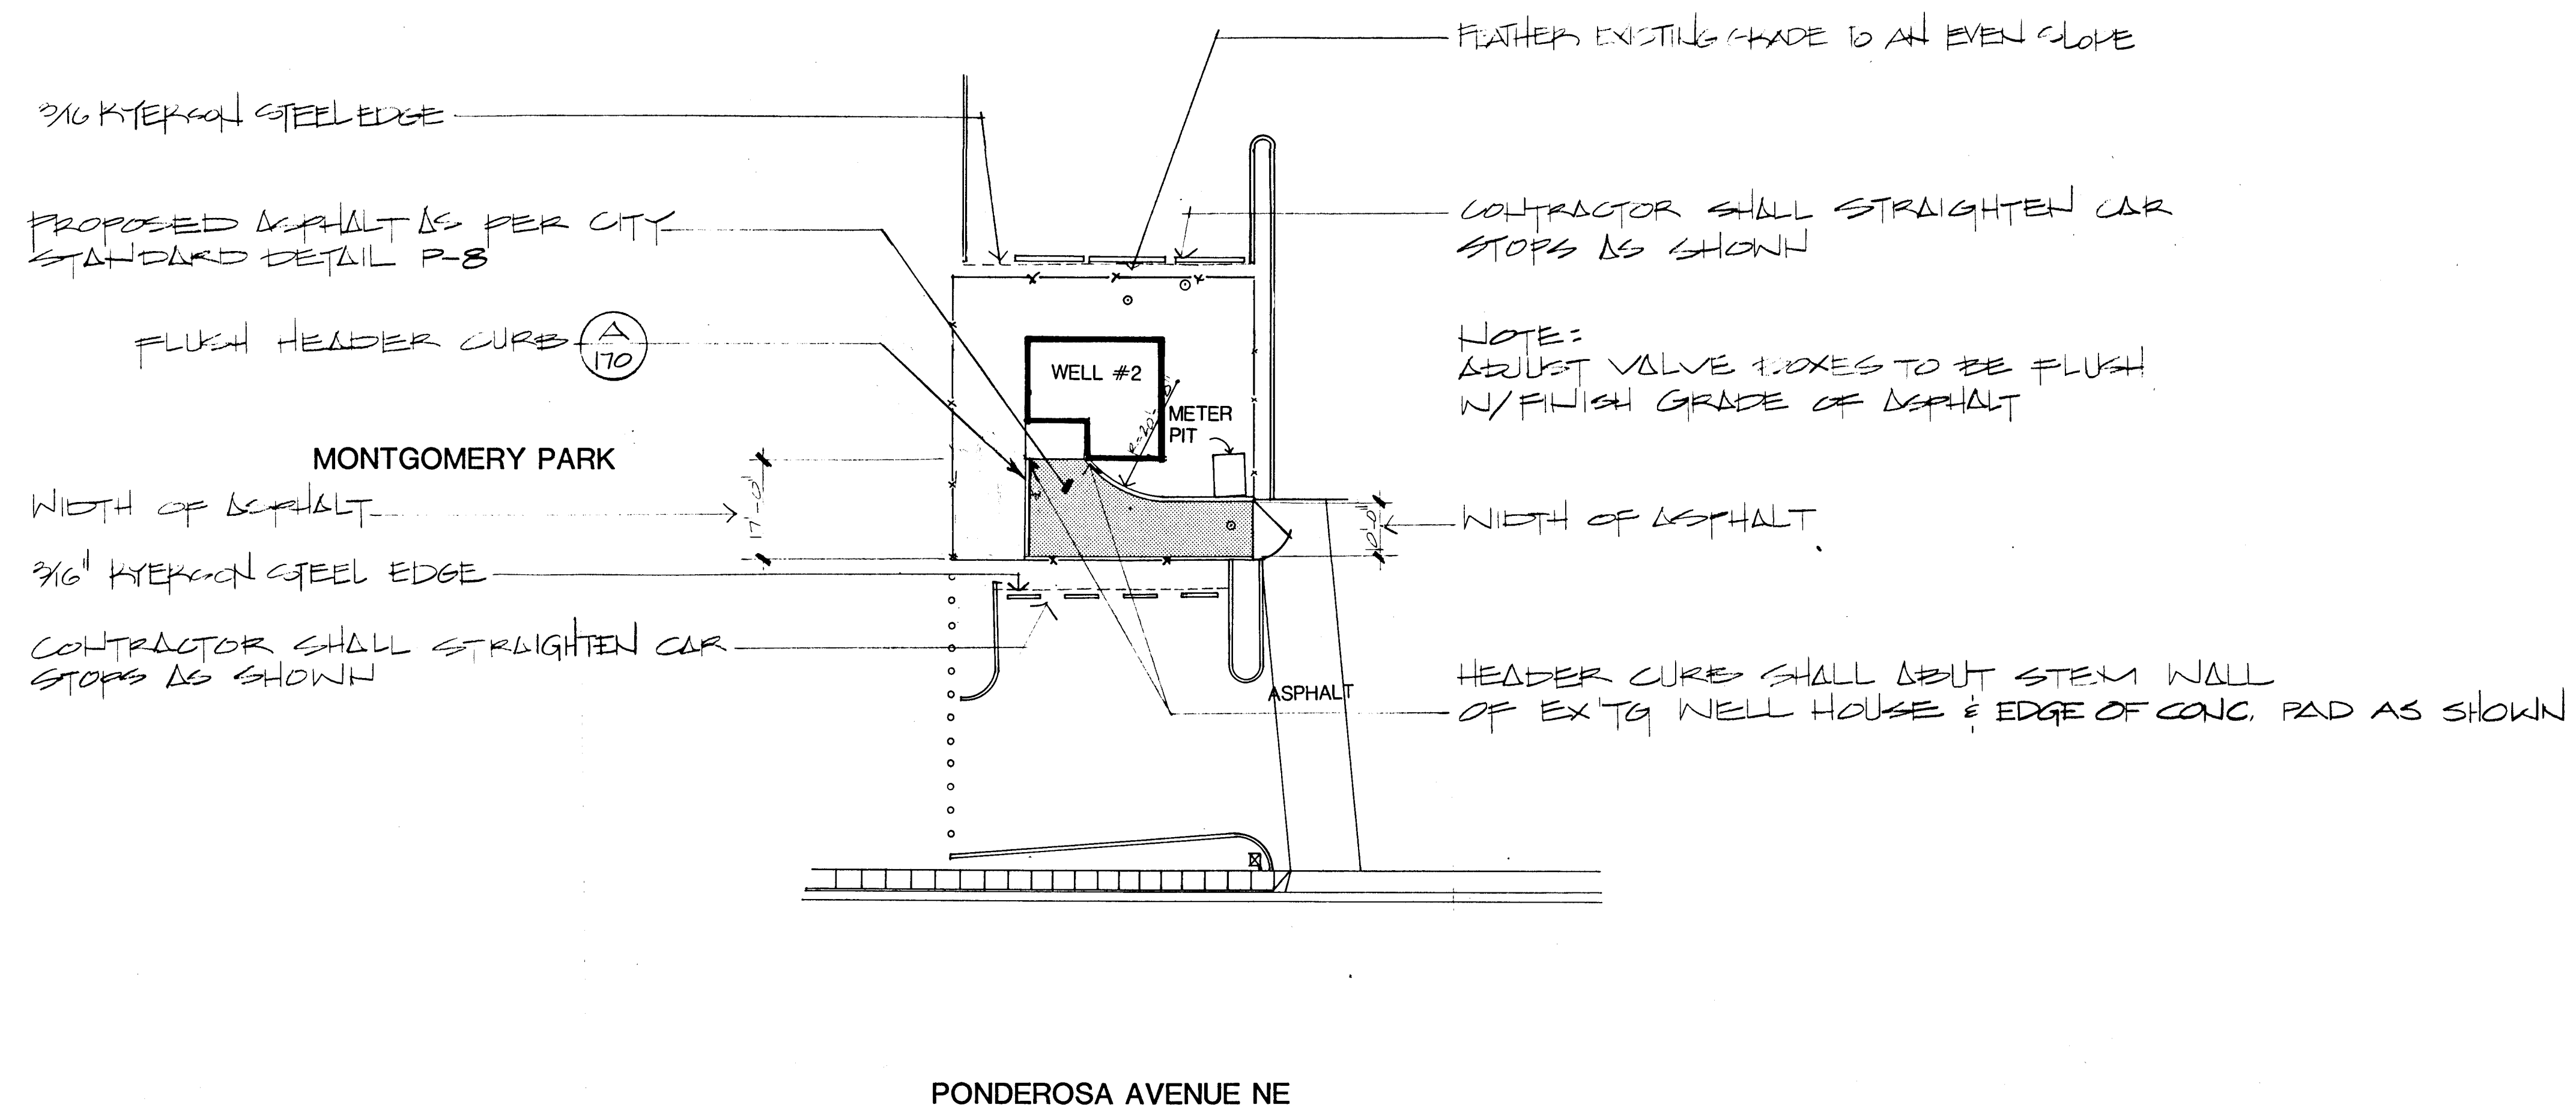


SCALE 1"=20'-0"

0 10 20 40

26 309712686

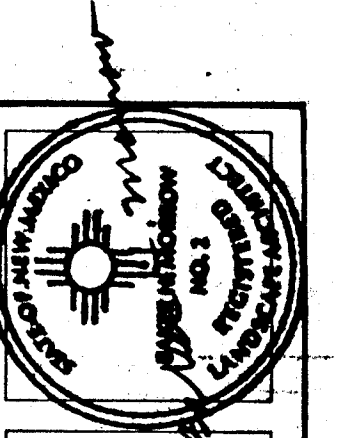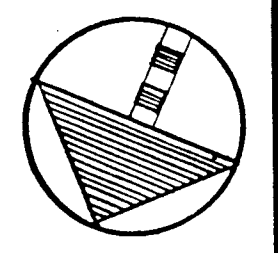

MORROW & COMPANY
LANDSCAPE ARCHITECTS
210 La Veta Drive NE
Albuquerque, New Mexico 87108
505-268-2266

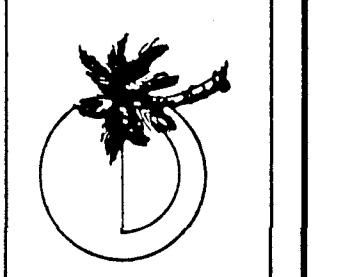


NOVEMBER
1986

AS BUILT

VOL-ANDIA WELL #2
5212 PONDEROSA AVENUE NE
CONSTRUCTION PLAN

LANDSCAPING IMPROVEMENTS FOR
WATER SYSTEM FACILITY SITES
WATER SYSTEMS DIVISION
CITY OF ALBUQUERQUE
ALBUQUERQUE, NEW MEXICO

SHEET
14
12

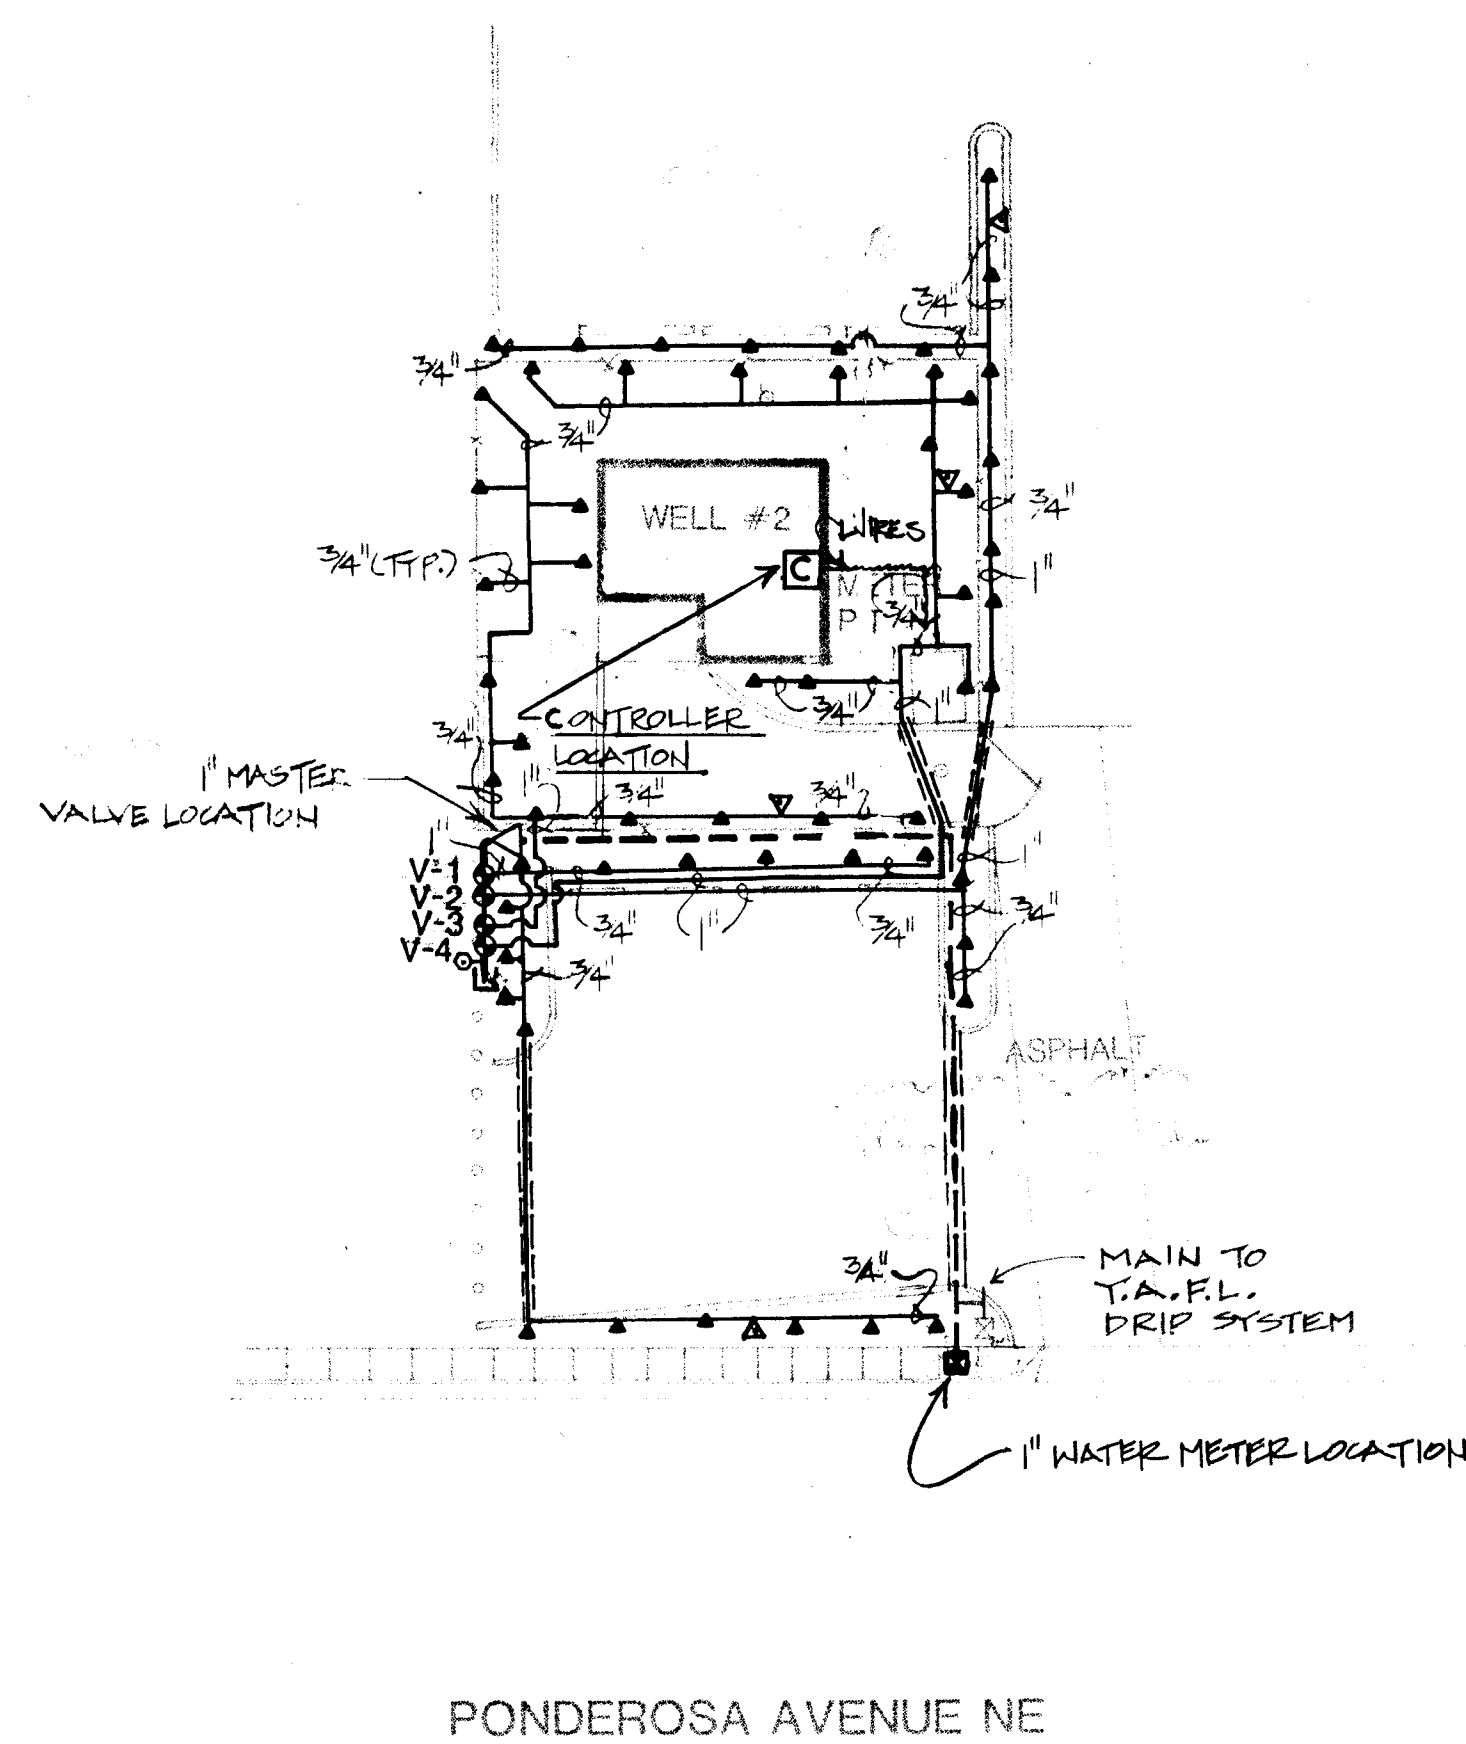

ELECTRICAL PANEL —

IRRIGATION CONTROLLER


 
CRC4IT #4

—1/2" RIGID STEEL CONDUIT, 24 VOLT CIRCUITS
TO REMOTE CONTROL VALVE


3/4" RIGID STEEL CONDUIT, 110 VOLT CIRCUIT

SCHEMATIC ASSEMBLY FOR 110VOLT ELECTRICAL
FROM SOURCE TO IRRIGATION CONTROLLER

SCALE 1"=20'-0"

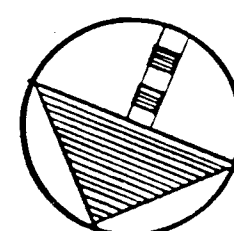

26 309712786

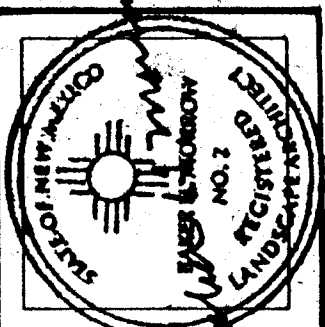

MORROW & COMPANY
LANDSCAPE ARCHITECTS
210 La Veta Drive NE
Albuquerque, New Mexico 87108
505 - 268-2266


NOVEMBER
1986

AS BUILT

VOL-ANDIA WELL #2
5212 PONDEROSA AVENUE NE
IRRIGATION PLAN

LANDSCAPING IMPROVEMENTS FOR
WATER SYSTEM FACILITY SITES
WATER SYSTEMS DIVISION
CITY OF ALBUQUERQUE
ALBUQUERQUE, NEW MEXICO

SHEET
148
OF
172

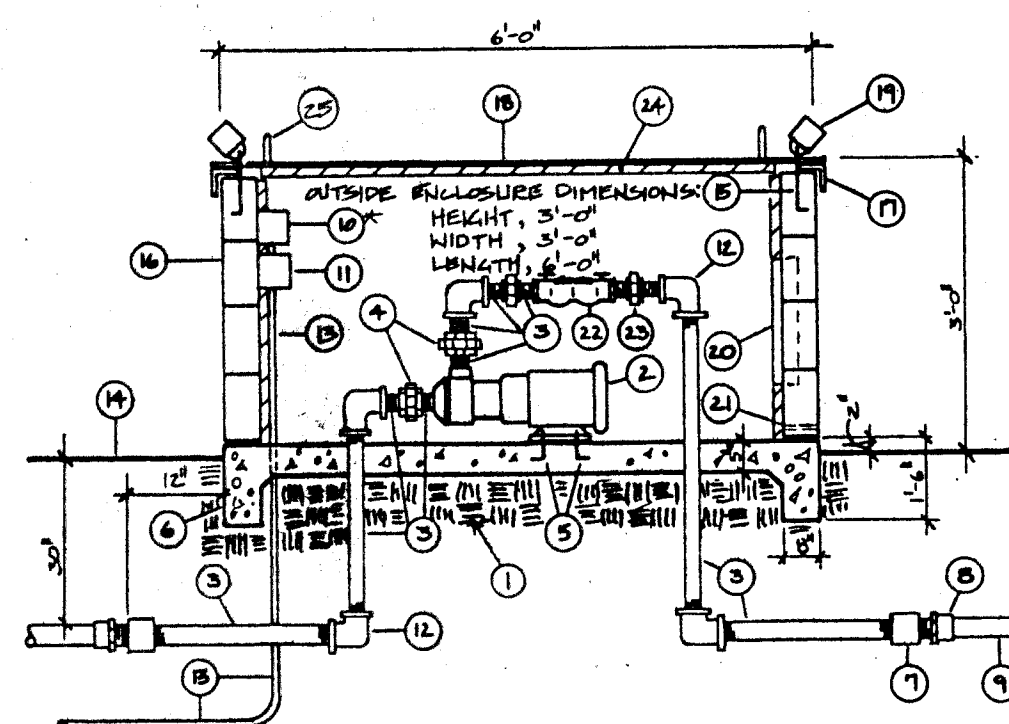


1. COMPACT SUB-GRADE TO 75X
2. FLINT AND WALLING MODEL NO. SPJ-20-1 SELF PRIMING, 2 HP SINGLE PHASE BOOSTER PUMP, (BOLT TO FLOOR).
3. 1 1/2" GALVANIZED UNION.
4. 1/2" x 1/4" ANCHOR BOLTS.
5. 3000 PSI CONCRETE.
6. 1 1/2" GALVANIZED COUPLING.
7. SCH. 80 PVC MALE ADAPTER.
8. PVC MAINLINE.
9. FURNAS, SD/SD-20 SAFETY DISCHARGE, STARTER DEVICE (INSTALL TO MAINLINE, INLET).
10. JUNCTION BOX, WEATHER PROOF.
11. 1 1/2" GALVANIZED R/L.
12. 3/4" RIGID AND COATED CONDUIT.
13. FINISH GRADE.
14. #4 REBAR LOOP (FOR LOCK).
15. CHU BLOCK (FILL WITH CONCRETE).
16. 90° ANGLE IRON (WELDED TO STEEL PLATE ON FOUR SIDES) 1/4" x 2 1/2".
17. 3/8" GALVANIZED STEEL PLATE 1/4" CUT-OUTS FOR #4 REBAR LOOPS, PAINT ENTIRE COVER W/ TWO COATS EACH PRIMER AND FLAT BLACK ENAMEL.
18. PAD LOCK BY OWNER.
19. WALL MOUNT METER, DAYTON ZEA-32 (INSTALL WIRE IN 3/4" CONDUIT TO JUNC. BOX).
20. 1/2" WEIR HOLE (ONE P/SIDE).

- NOTES:
1. PAINT EXTERIOR CHU BLOCK WITH THREE COATS OF SEMI-GLOSS WATER ENAMEL. COLOR TO MATCH EXISTING WELL HOUSE.
 2. INSTALL A 30AMP CIRCUIT BREAKER IN EXISTING ELEC. PANEL OF WELL HOUSE.
 3. INSTALL A 2 1/2" W/GROUND CONDUITOR IN 3/4" CONDUIT FROM EXISTING ELEC. PANEL TO JUNCTION BOX.
 4. WIRE LEADS FROM PUMP AND HEATER TO JUNCTION BOX.
 5. LEADS FROM PUMP AND HEATER SHALL BE INSTALLED IN 3/4" CONDUIT.
 6. AVAILABLE FROM S.W.T. DISTRIBUTORS, ALBUQU., 345-6216

BOOSTER PUMP AND DOUBLE CHECK ASSEMBLY

APPENDUM #1

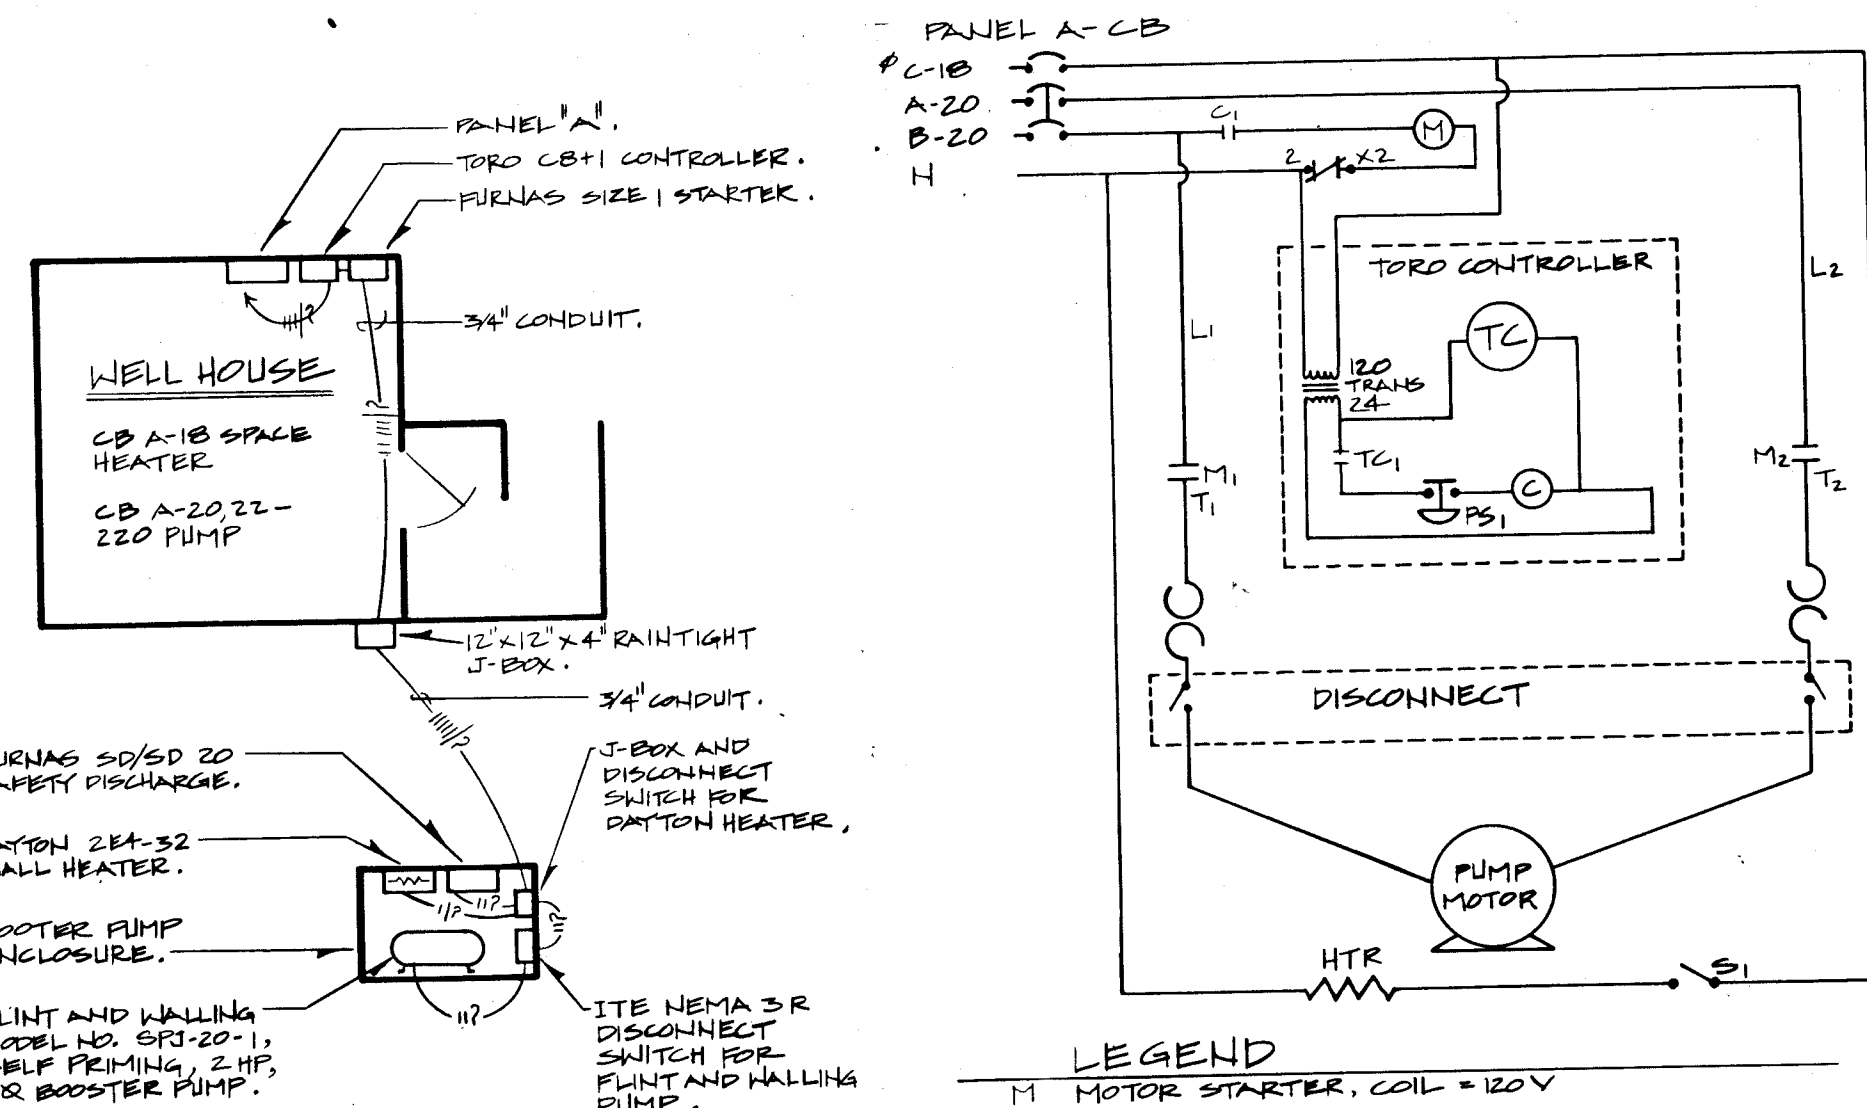


LEGEND

M MOTOR STARTER, COIL = 120V
 C IRRIGATION CONTROL RELAY, COIL = 24V
 TC TIME CLOCK = 24 VOLT
 PS1 SAFETY DISCHARGE PRESSURE SWITCH = 24V
 HTR SPACE HEATER = 120 V

SCHEMATIC AS-BUILT FOR 110VOLT AND 24 VOLT ELECTRICAL

NO SCALE

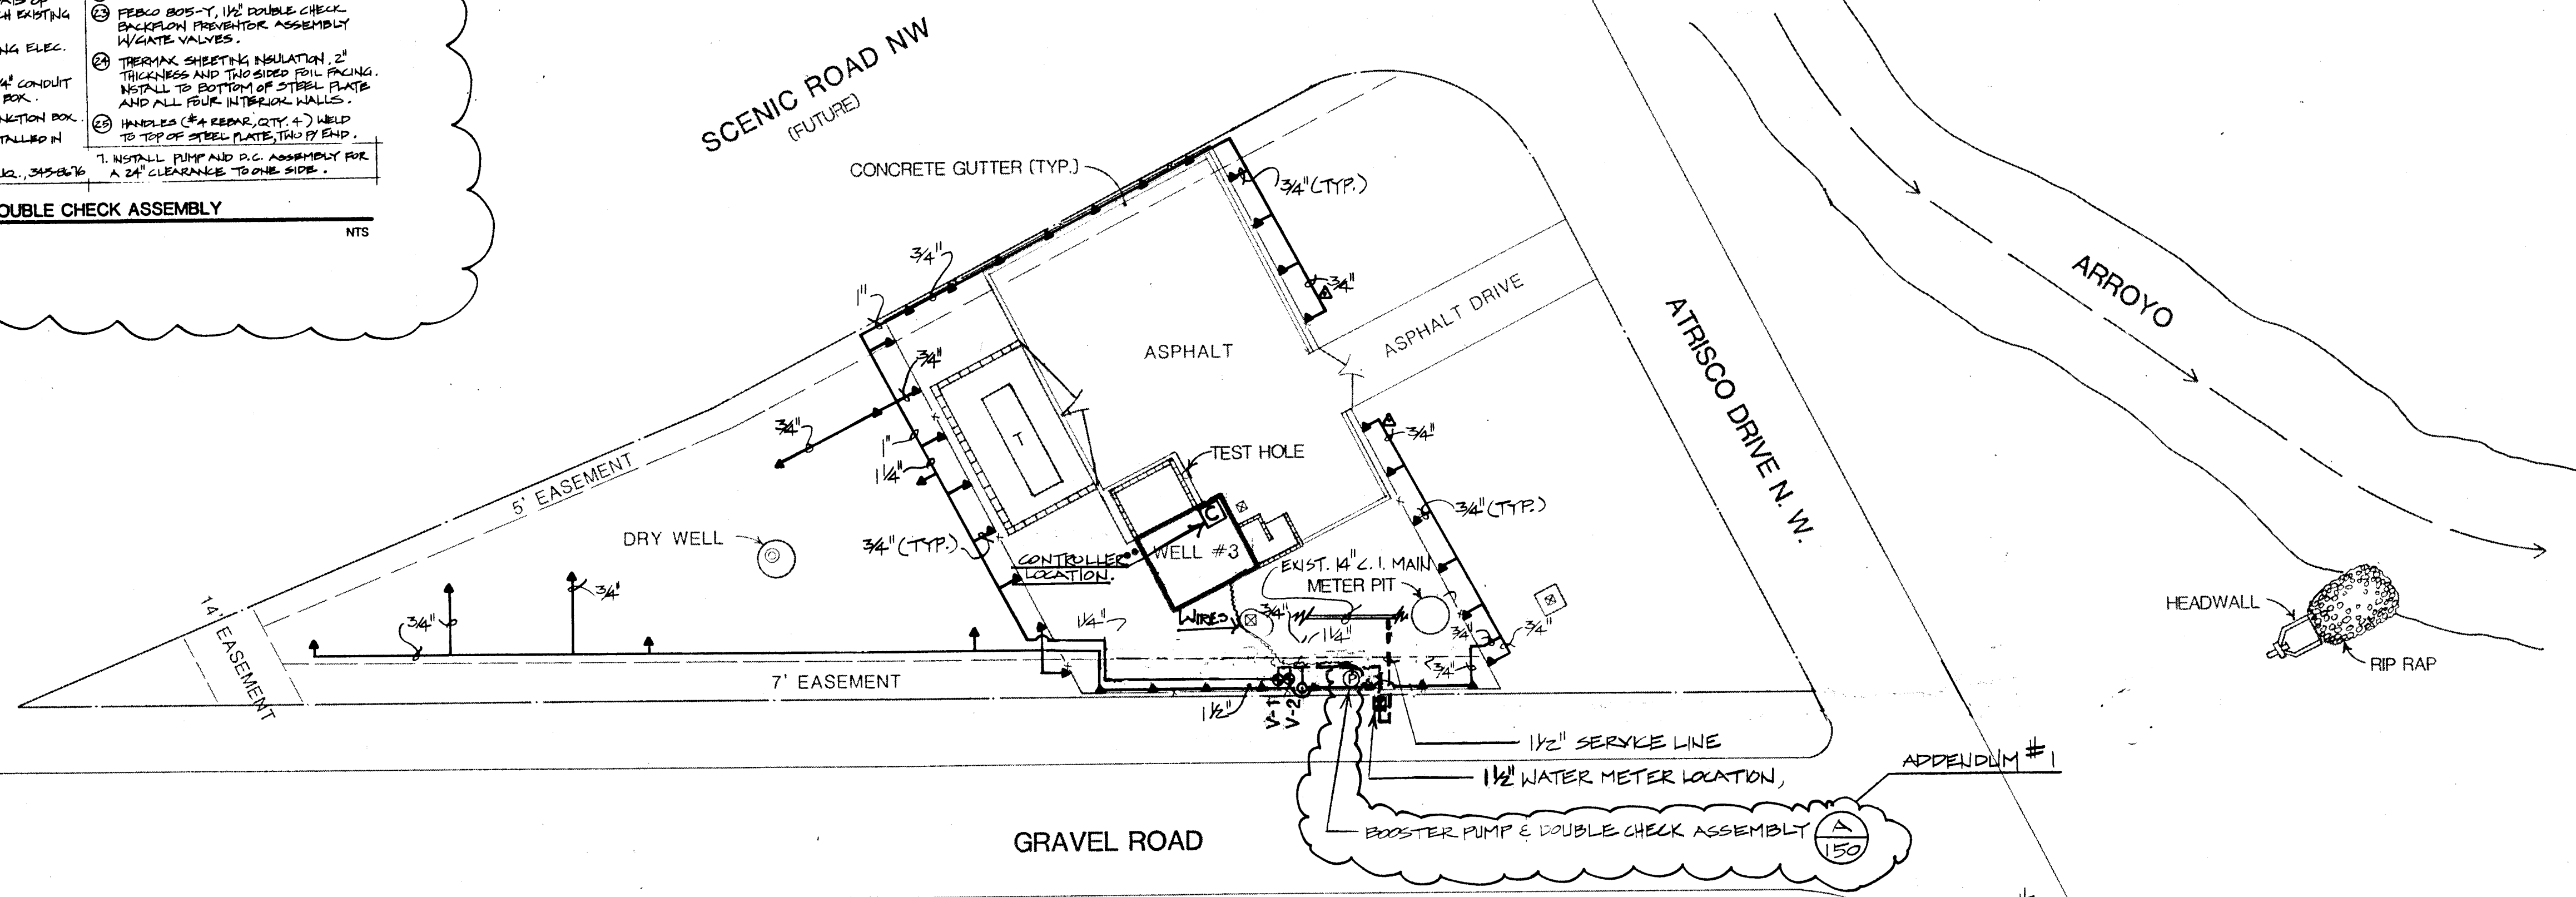

NOTE: CONTRACTOR SHALL INSTALL WATER METER, BOOSTER PUMP AND DOUBLE CHECK ASSEMBLY, MAINLINE, MANUAL DRAIN VALVES # V-1 AND # V-2 1'-0" NORTH OF 7' EASEMENT.

ELECTRICAL PANEL — IRRIGATION CONTROLLER

CIRCUIT # 8 (TIMER)


CIRCUIT # 22 (PUMP)

1/2" RIGID STEEL CONDUIT, 24 VOLT CIRCUITS TO REMOTE CONTROL VALVES

3/4" RIGID STEEL CONDUIT, 110VOLT CIRCUIT

SCHEMATIC AS-BUILT FOR 110VOLT ELECTRICAL FROM SOURCE TO IRRIGATION CONTROLLER

SCALE 1"=20'-0"

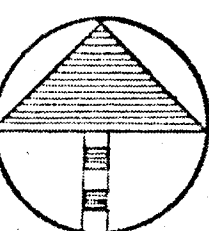


26 30 97 12 98 6

LOW JAP 'HDL' (44) (L 170)
PAR QUI (22)

NATIVE GROUND COVER MIX 'A' (TYP. IN UNPAVED AREAS)

CLIP ARI (5)
(15 GAL)



POP ACU (2)
(15 GAL)

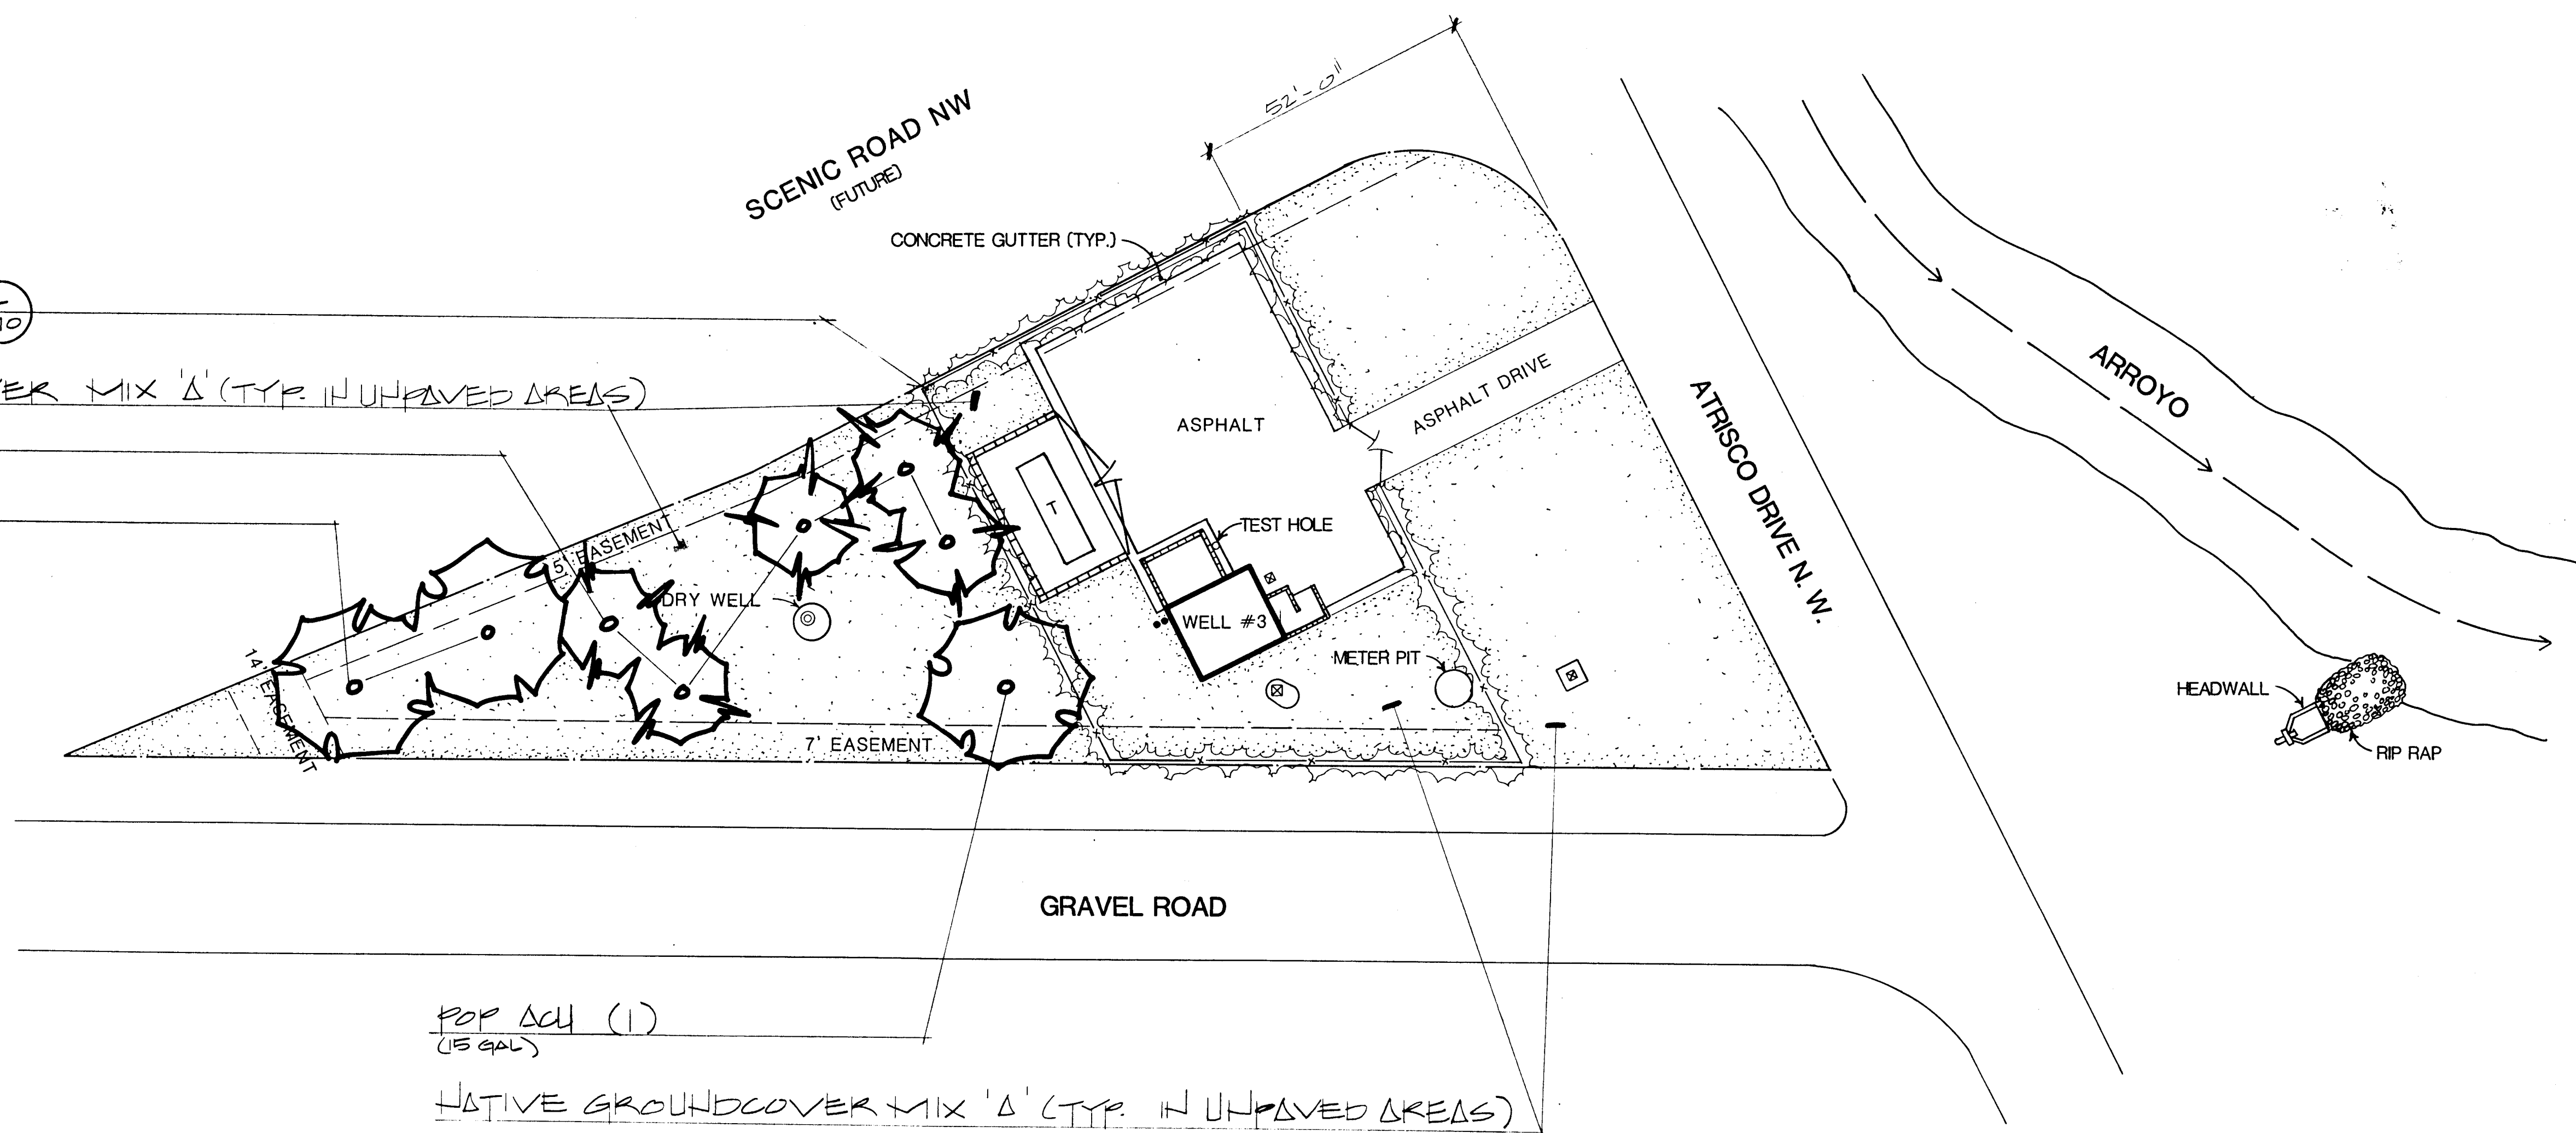

NOTE:
ALL HARD CONSTRUCTION ON
THIS SHEET IS EXISTING.

SCALE 1"=20'-0"
0 10 20 40

26 309713086

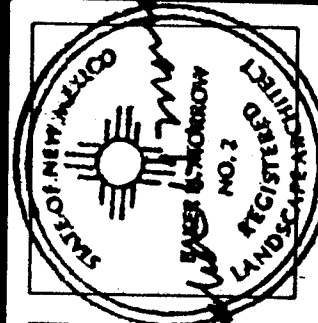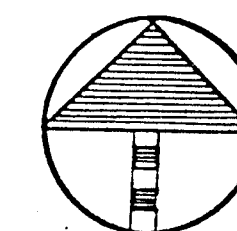

MORROW & COMPANY
LANDSCAPE ARCHITECTS
210 La Veta Drive NE
Albuquerque, New Mexico 87108
505-268-2266




NOVEMBER
1986

VOLCANO CLIFFS WELL #3
7231 ATRISCO DRIVE NW
PLANTING PLAN

LANDSCAPING IMPROVEMENTS FOR
WATER SYSTEM FACILITY SITES
WATER SYSTEMS DIVISION
CITY OF ALBUQUERQUE
ALBUQUERQUE, NEW MEXICO

SHEET
101
172

HOLLYWOOD AVE. NE.

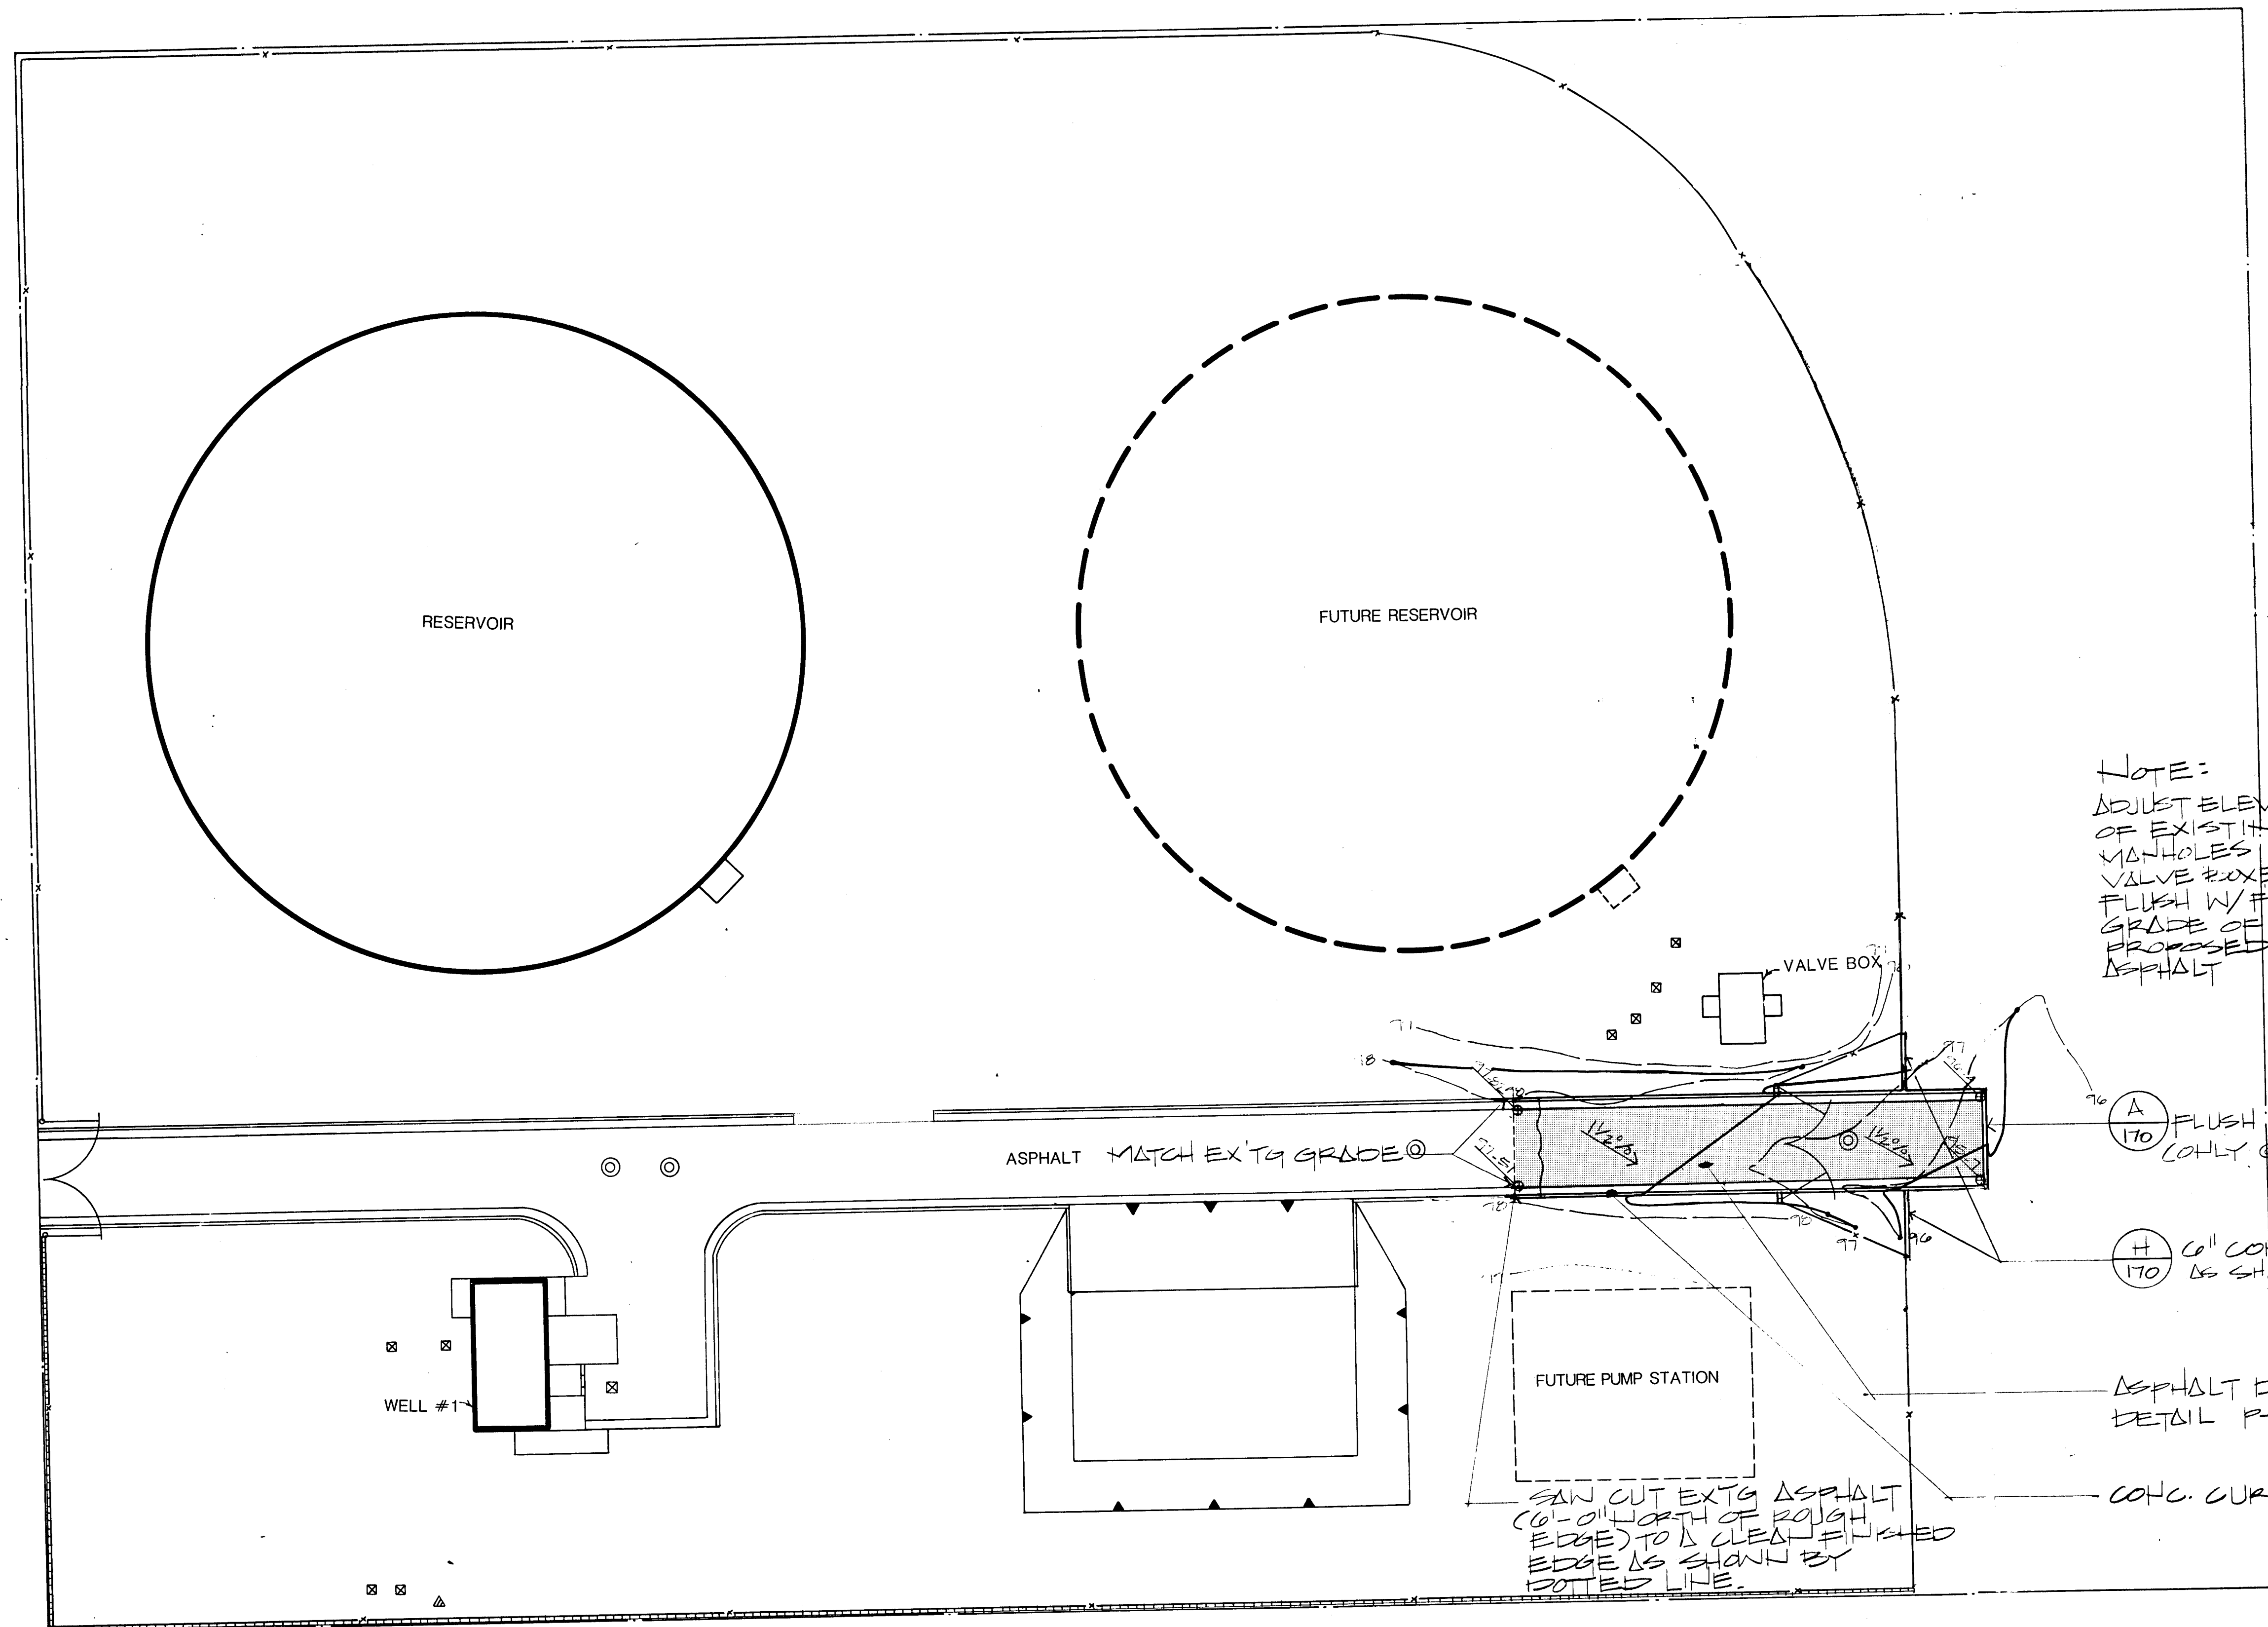

NOTE:
ADJUST ELEVATION
OF EXISTING
MANHOLES &
VALVE BOXES TO BE
FLUSH W/ FINISH
GRADE OF
PROPOSED
ASPHALT

PASEO DEL NORTE NE

(A) FLUSH HEADER CURB
(ONLY @ SOUTH END OF DRIVE)


(H) 6" CONC. LOW STRIP (TYP.
AS SHOWN BY SHADED LINE)

ASPHALT DRIVE AS PER CITY STANDARD
DETAIL P-8


CONC. CURB & GUTTER TO MATCH EX'G

SAW CUT EXT'G ASPHALT
6'-0" NORTH OF ROUGH
EDGE TO A CLEAN FINISHED
EDGE AS SHOWN BY
DOTTED LINE.


SCALE 1"=20'-0"

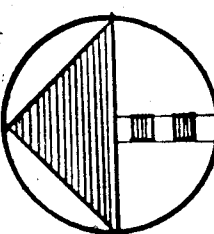

26 30.9713186

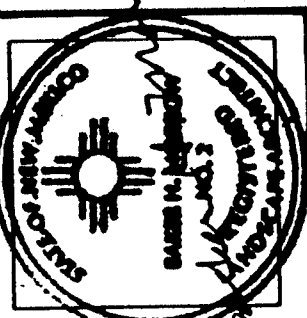

MORROW & COMPANY
LANDSCAPE ARCHITECTS
210 La Veta Drive NE
Albuquerque, New Mexico 87108
505-268-2266

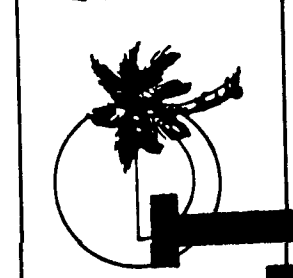


NOVEMBER
1986

W.A. WEBSTER WELL #1 & RESERVOIR
8001 LOS ANGELES NE
CONSTRUCTION PLAN / GRADING PLAN

LANDSCAPING IMPROVEMENTS FOR
WATER SYSTEM FACILITY SITES
WATER SYSTEMS DIVISION
CITY OF ALBUQUERQUE
ALBUQUERQUE, NEW MEXICO


SHEET
152
OF
172

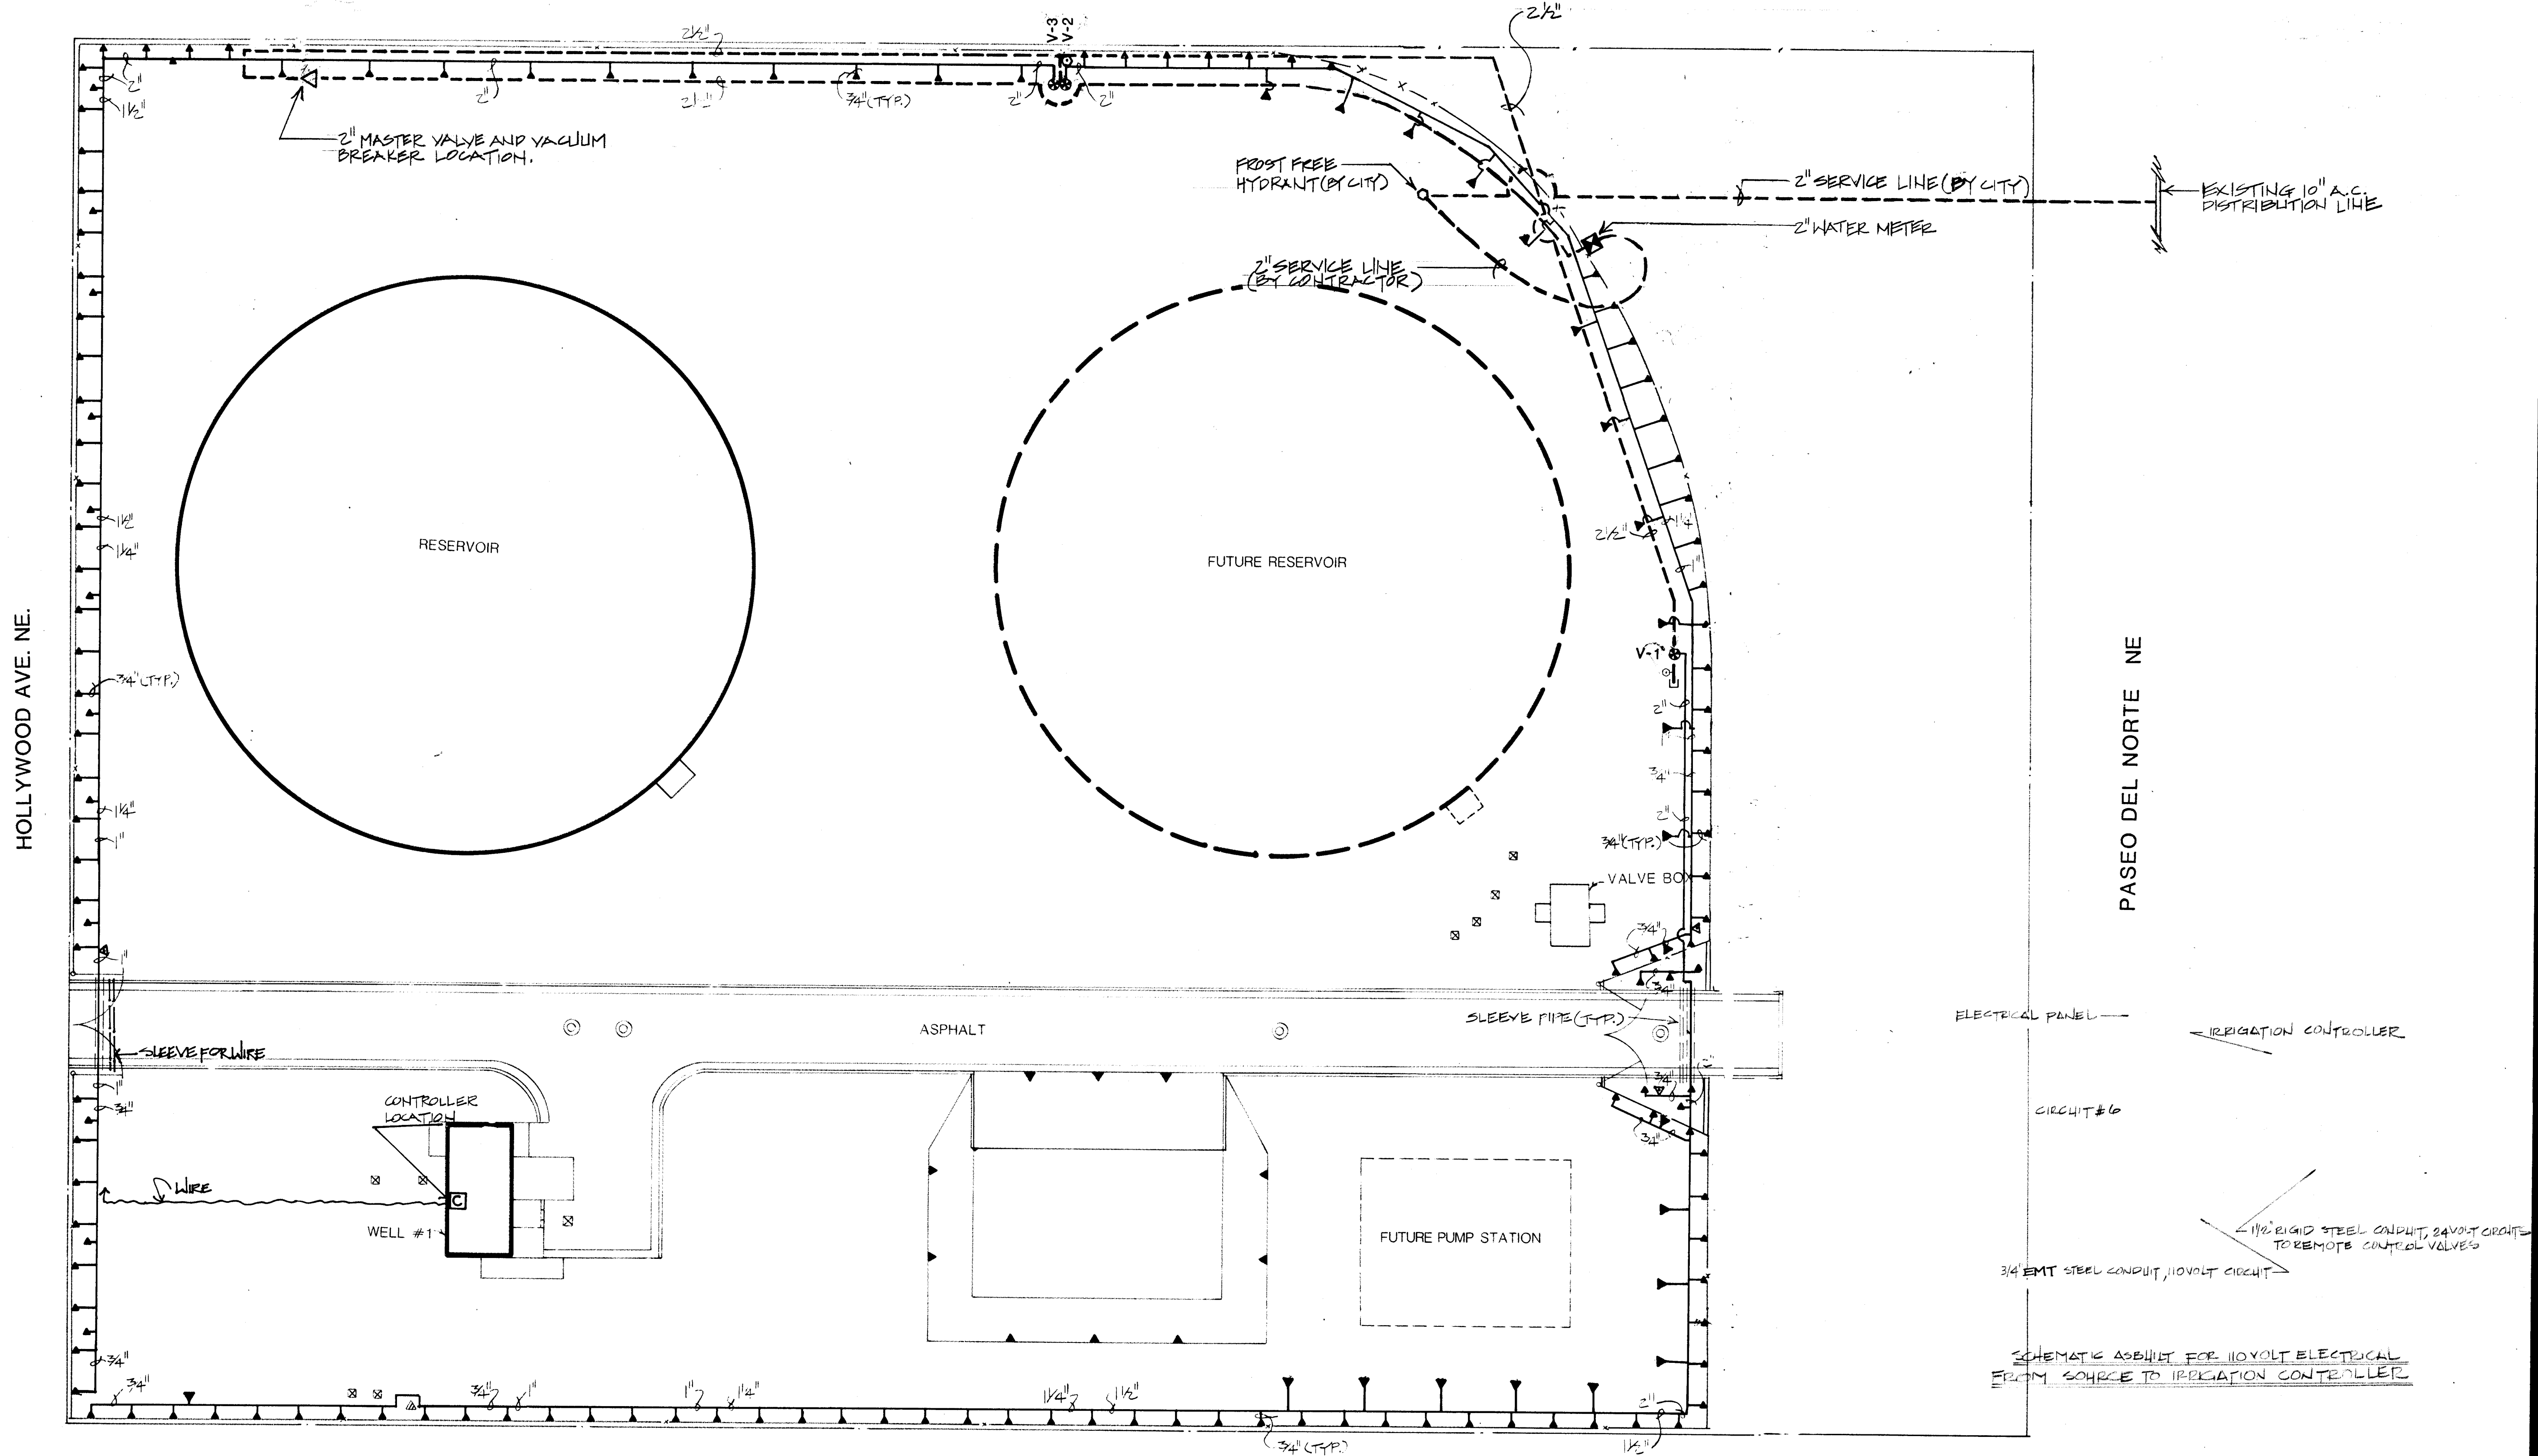


HOLLYWOOD AVE. NE.

PASEO DEL NORTE NE

 
SCALE 1"=20'-0"



26 309713286

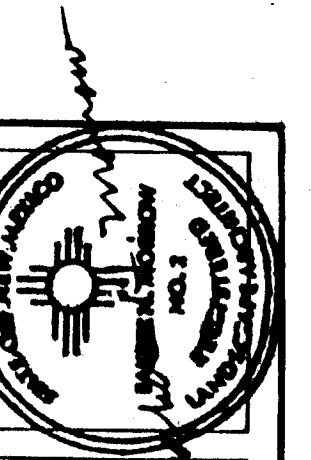

MORROW & COMPANY
LANDSCAPE ARCHITECTS
210 La Veta Drive NE
Albuquerque, New Mexico 87108
505-268-2266


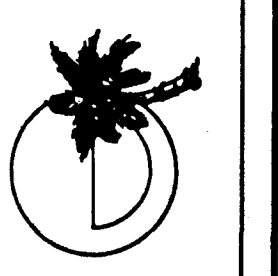


NOVEMBER
1986

W.A. WEBSTER WELL #1 & RESERVOIR
8001 LOS ANGELES NE
AS BUILT
IRRIGATION PLAN

LANDSCAPING IMPROVEMENTS FOR
WATER SYSTEM FACILITY SITES
WATER SYSTEMS DIVISION
CITY OF ALBUQUERQUE
ALBUQUERQUE, NEW MEXICO

SHEET
133
172

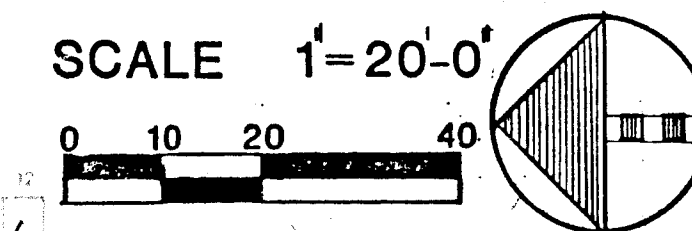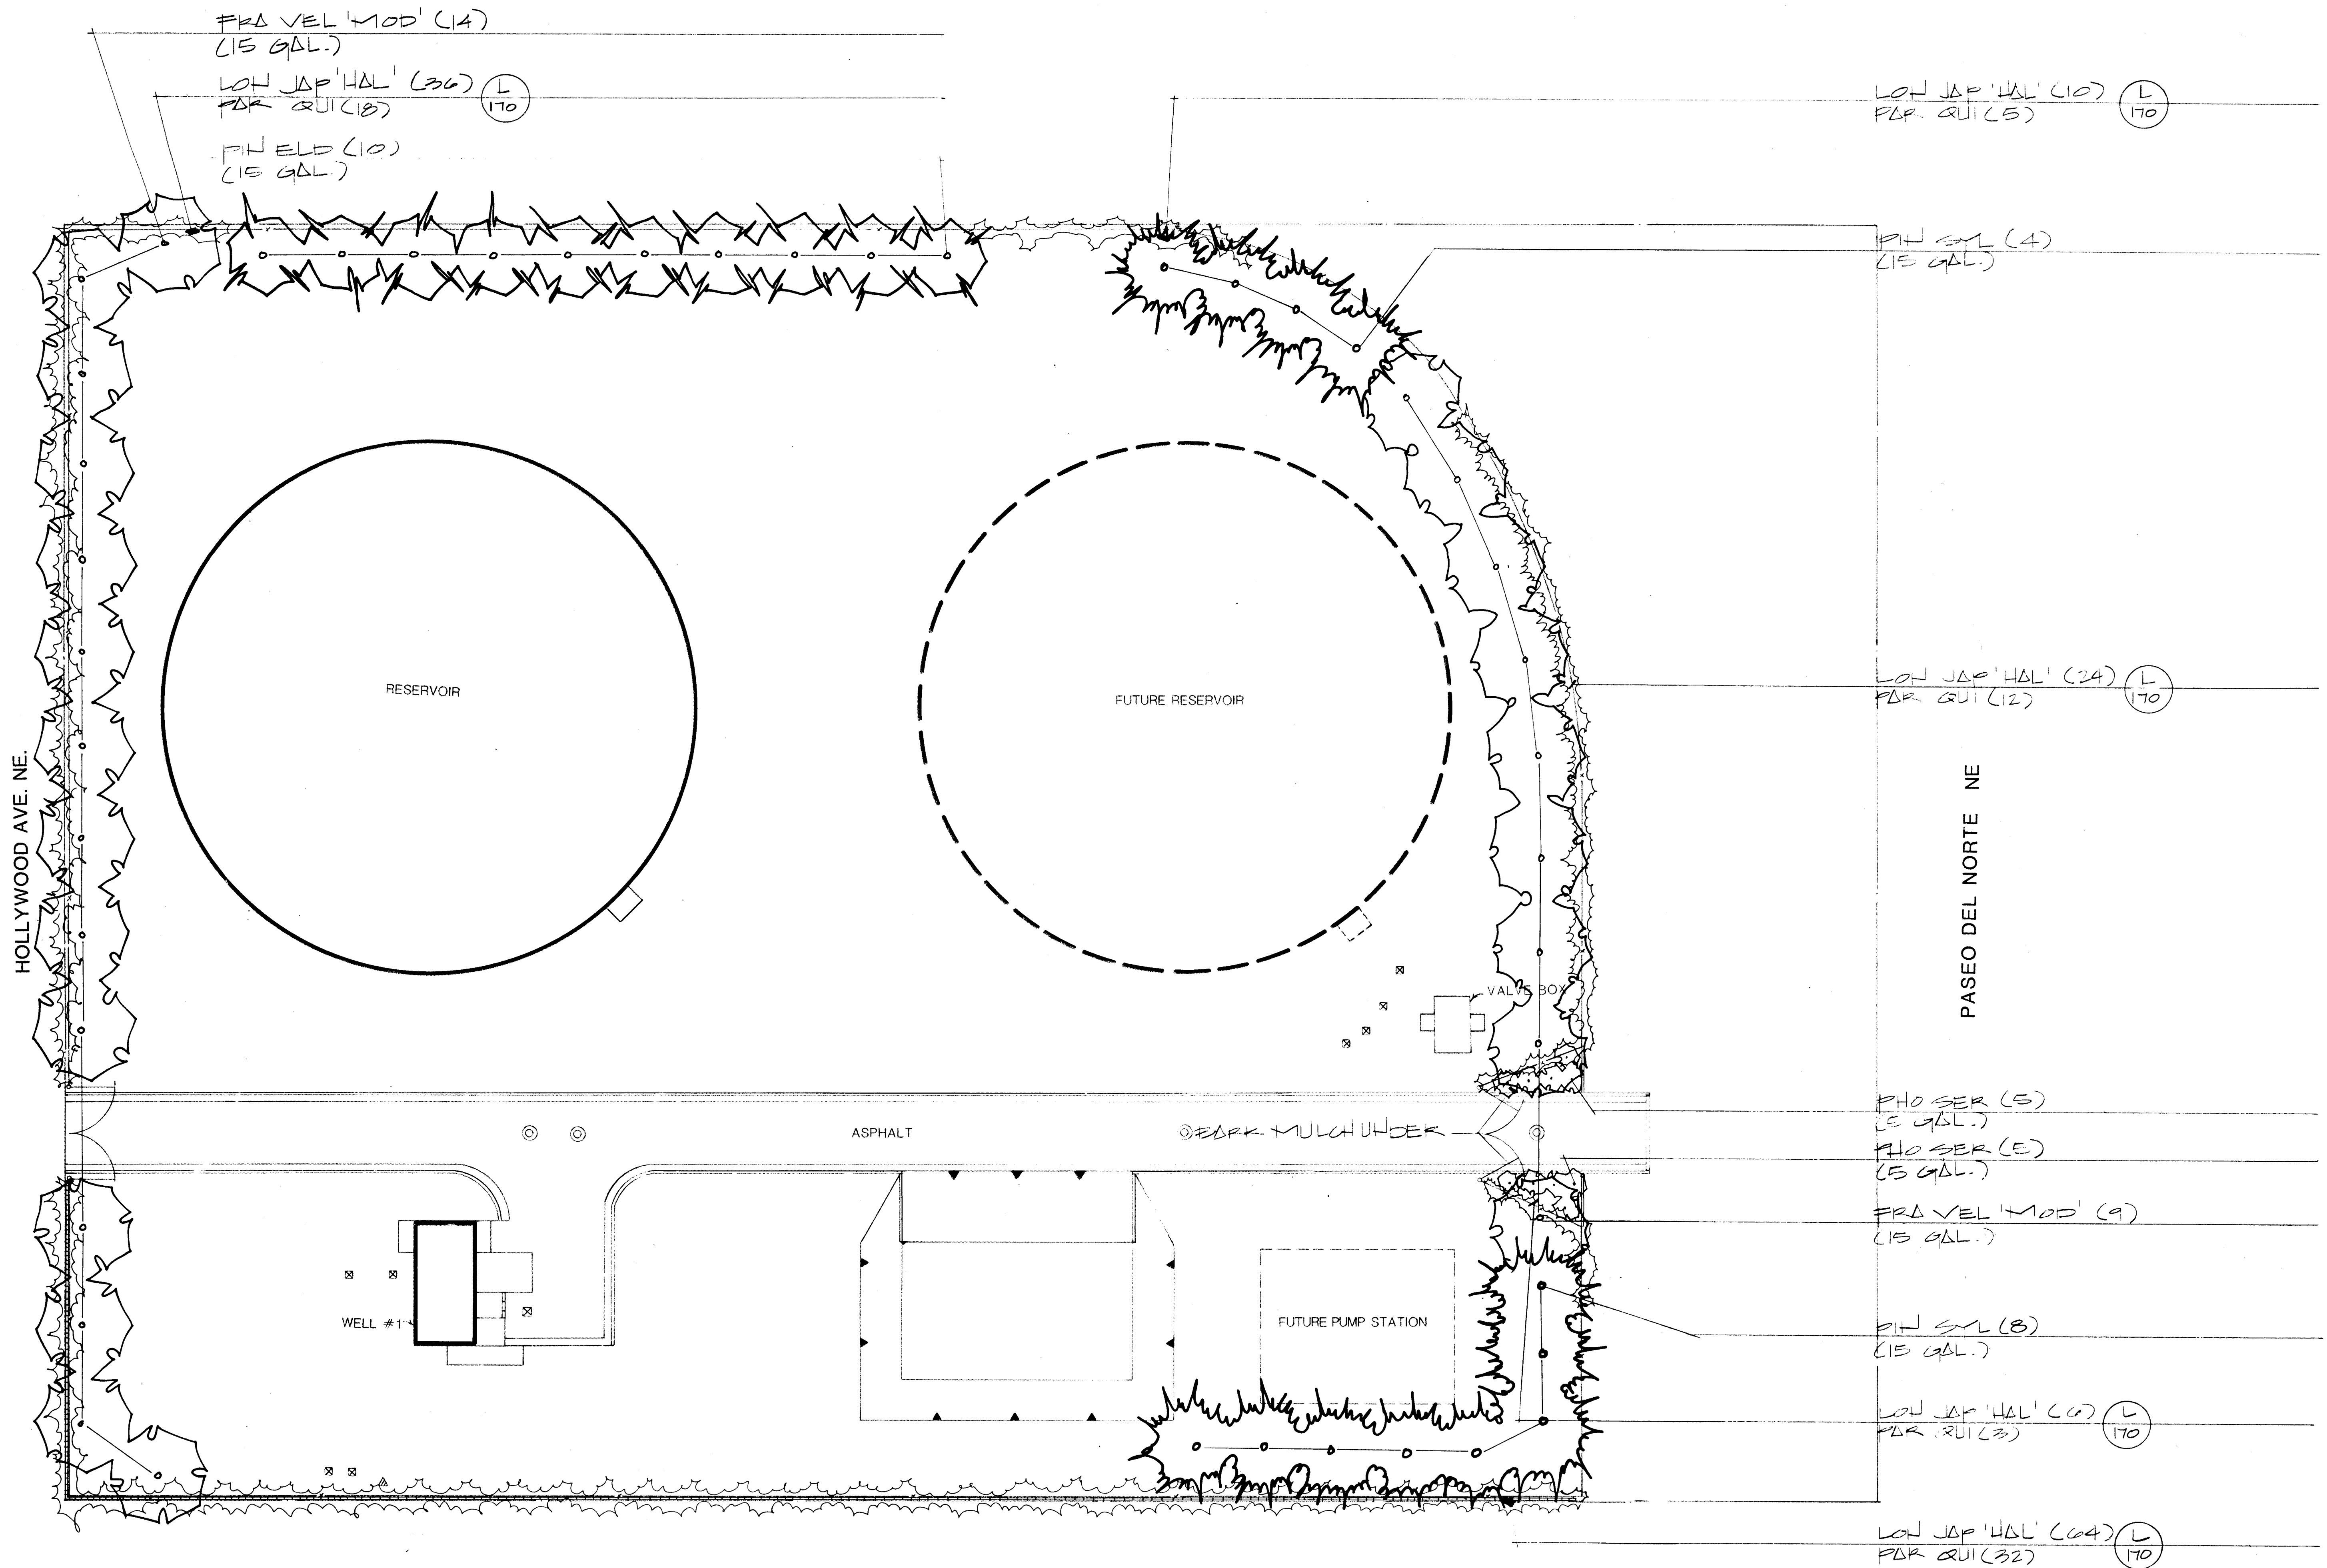

26 309713386



MORROW & COMPANY
LANDSCAPE ARCHITECTS
210 La Veta Drive NE
Albuquerque, New Mexico 87108
505-268-2266

NOVEMBER
1986

W.A. WEBSTER WELL #1 & RESERVOIR
8001 LOS ANGELES NE
AS BUILT
PLANTING PLAN

LANDSCAPING IMPROVEMENTS FOR
WATER SYSTEM FACILITY SITES
WATER SYSTEMS DIVISION
CITY OF ALBUQUERQUE
ALBUQUERQUE, NEW MEXICO

SHEET
11
12

UNSER BLVD.

NOTE: POND IS NOT WATER UTILITIES DEPT. PROPERTY

RIP RAP

RIP RAP


DIRT ACCESS ROAD

CONCRETE

BM-5102.80
TOP OF CURB
EAST END


SARRACINO PLACE

EXT. MOUND OF SOIL ON EAST SIDE
OF GATE SHALL BE FEATHERED UP FROM
ASPHALT TO ASSURE COMPLETE DRAINAGE
ONTO ASPHALT

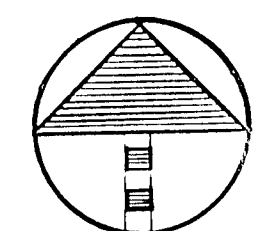

SCALE 1"=20'-0"

26 309713486

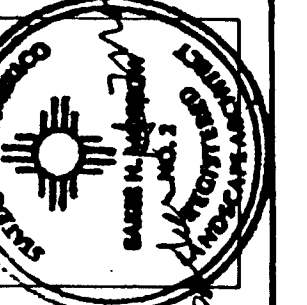

MORROW & COMPANY
LANDSCAPE ARCHITECTS
210 La Veta Drive NE
Albuquerque, New Mexico 87108
505-268-2266



NOVEMBER
1986



AS BUILT

WEST MESA WELL #4
7721 SARRACINO PLACE NW
GRADING PLAN


LANDSCAPING IMPROVEMENTS FOR
WATER SYSTEM FACILITY SITES
WATER SYSTEMS DIVISION
CITY OF ALBUQUERQUE
ALBUQUERQUE, NEW MEXICO

SHEET
109
112


UNSER BLVD.

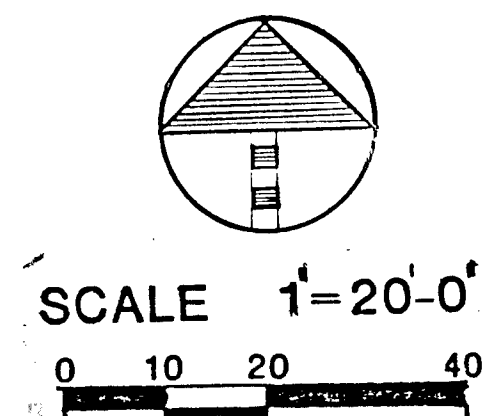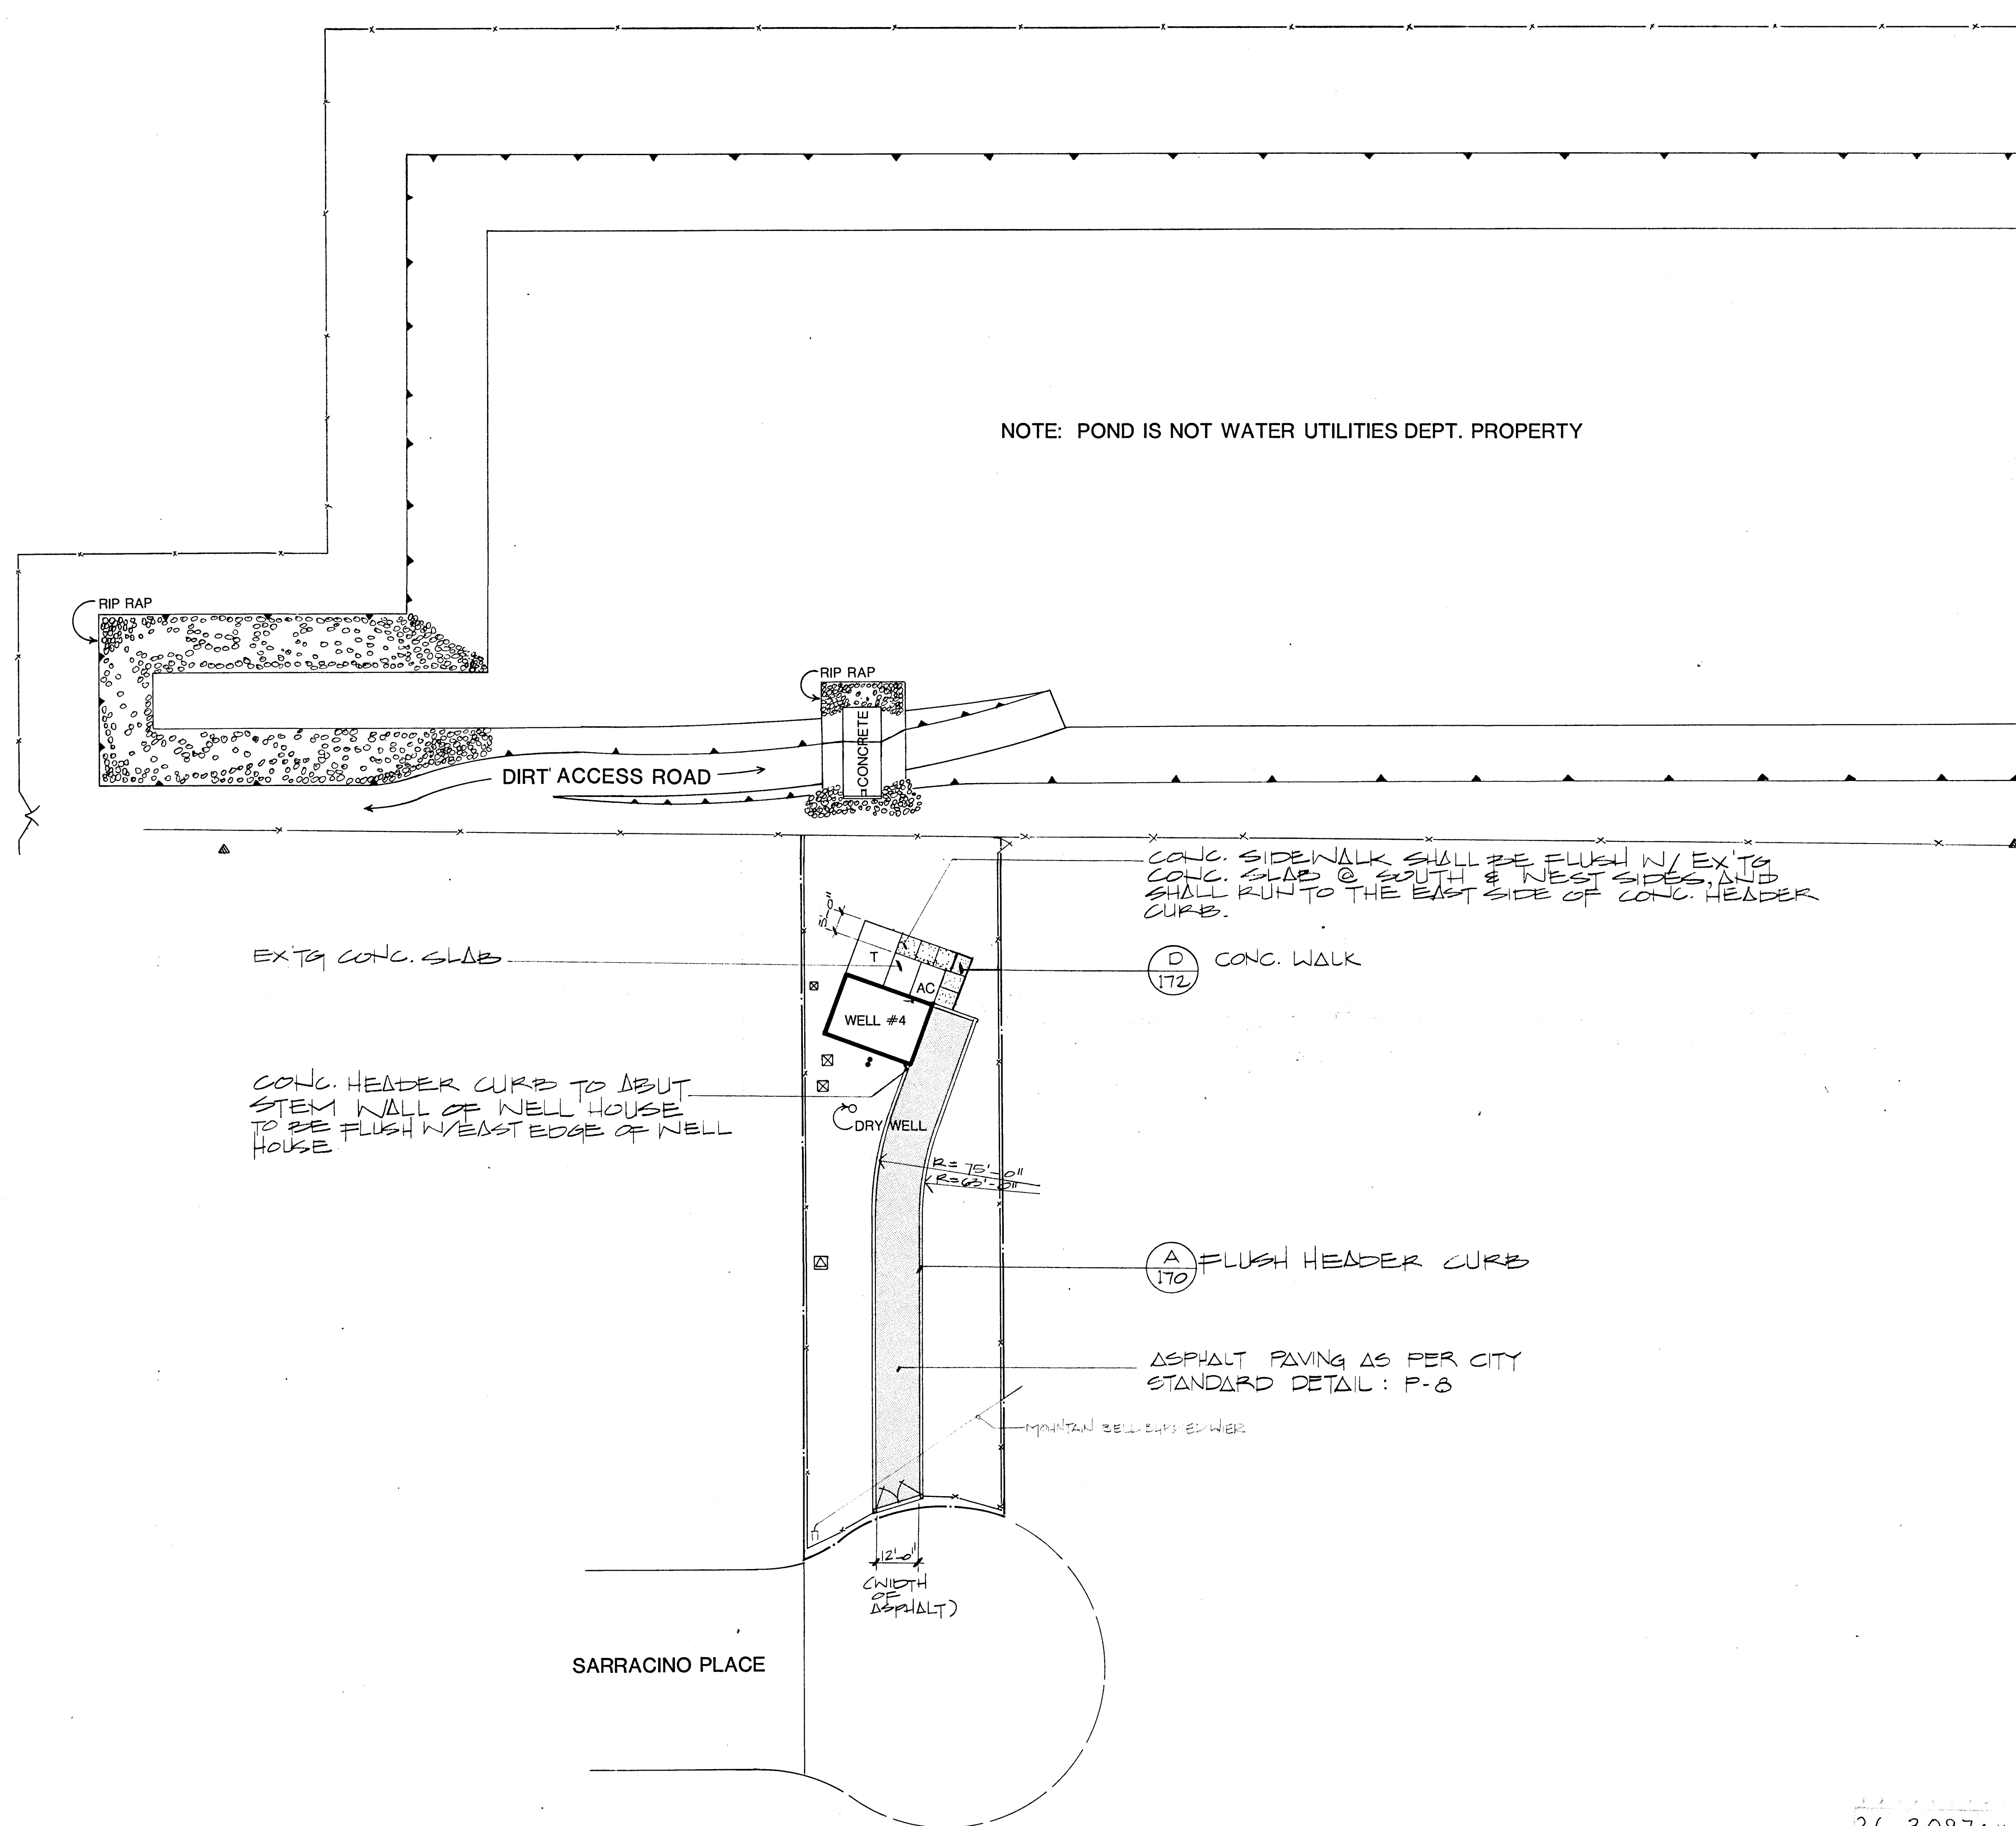

26 309714586

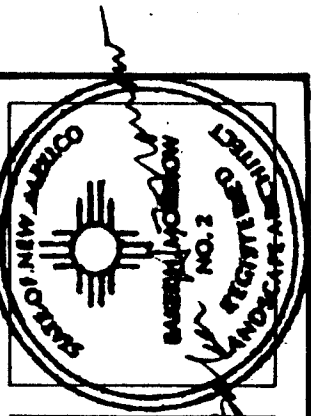

MORROW & COMPANY
LANDSCAPE ARCHITECTS
210 La Veta Drive NE
Albuquerque, New Mexico 87108
505-268-2266

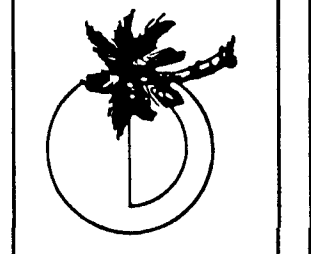


NOVEMBER
1986

AS BUILT

WEST MESA WELL #4
7721 SARRACINO PLACE NW
CONSTRUCTION PLAN

LANDSCAPING IMPROVEMENTS FOR
WATER SYSTEM FACILITY SITES
WATER SYSTEMS DIVISION
CITY OF ALBUQUERQUE
ALBUQUERQUE, NEW MEXICO

SHEET
18
172

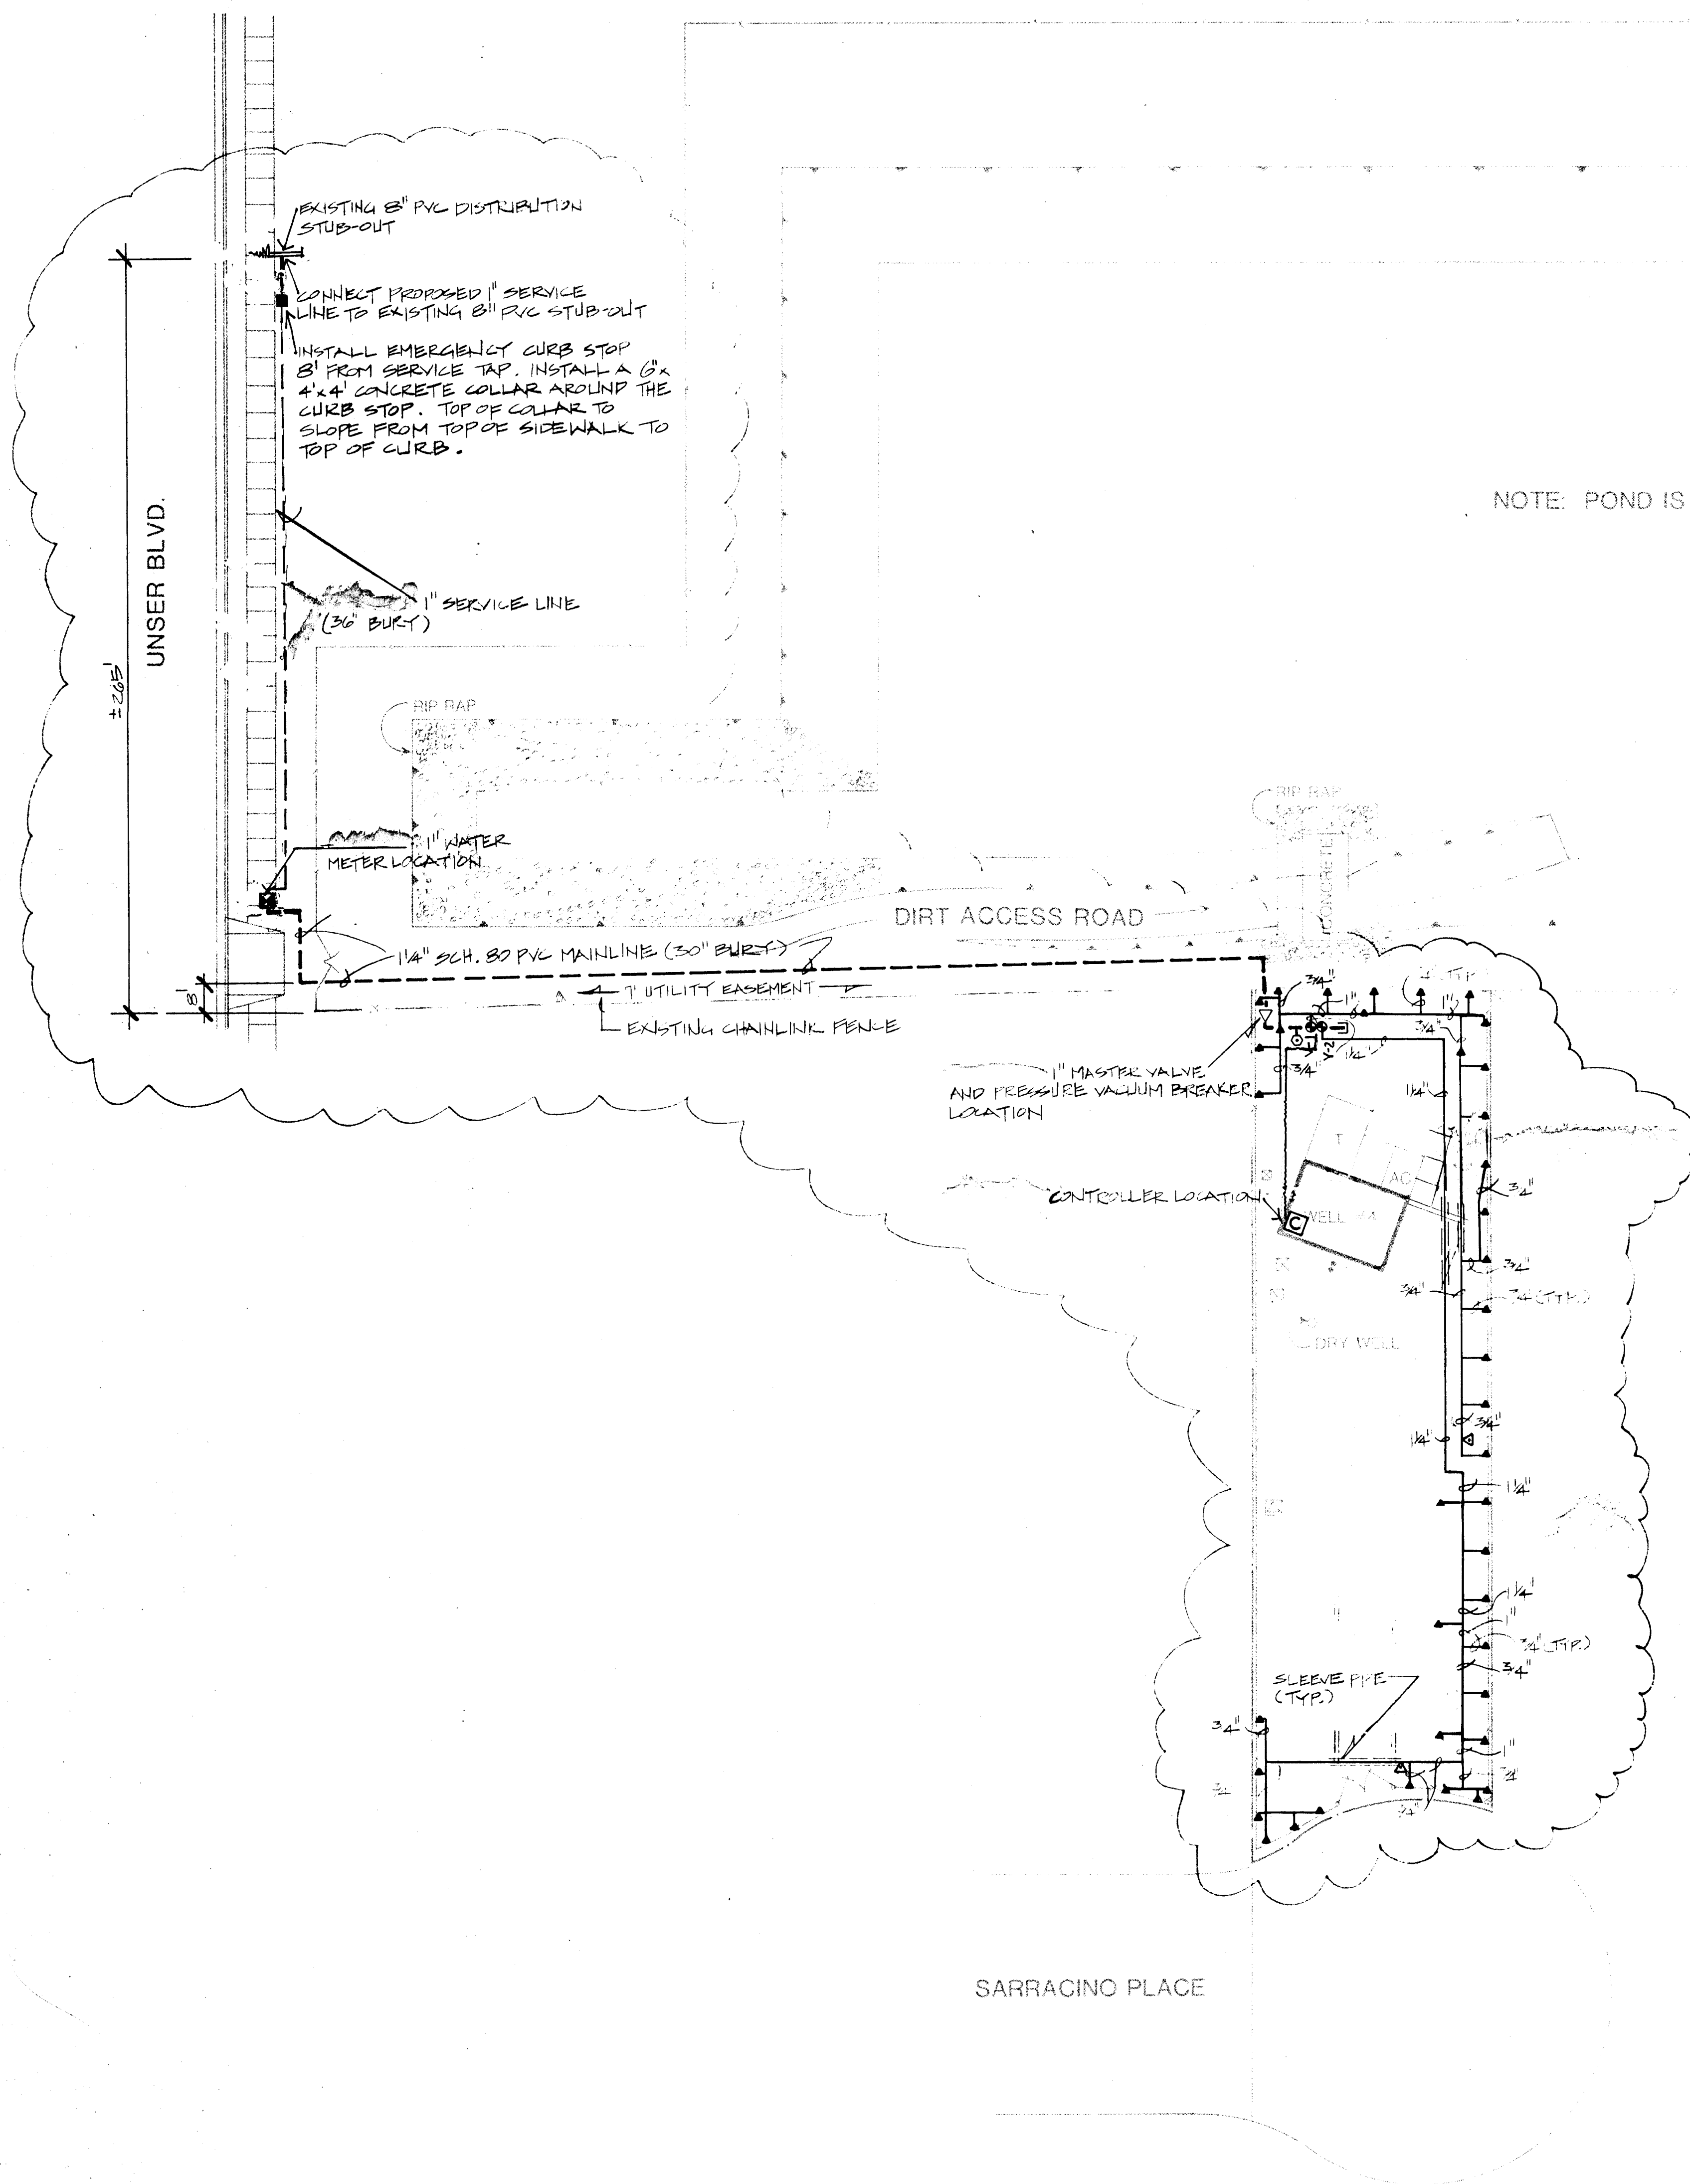

NOTE: POND IS NOT WATER UTILITIES DEPT. PROPERTY

REVISED 6-25-87

ELECTRICAL PANEL


CIRCUIT #

IRRIGATION CONTROLLER


1/2" RIGID STEEL CONDUIT, 24 VOLT CIRCUITS TO REMOTE CONTROL VALVES.

3/4" RIGID STEEL CONDUIT, 110 VOLT CIRCUIT


SCHEMATIC AS BUILT FOR 110 VOLT ELECTRICAL FROM SOURCE TO IRRIGATION CONTROLLER

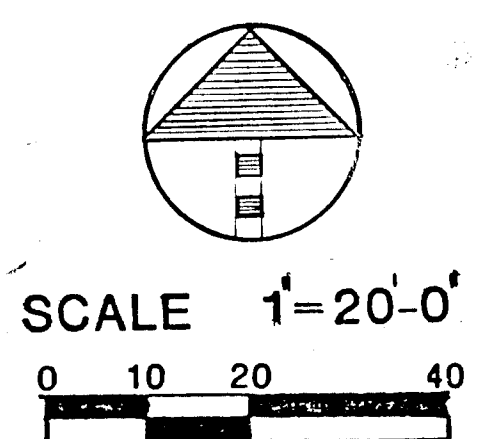

26 309713686

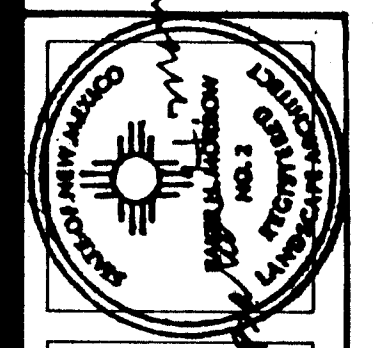

MORROW & COMPANY
LANDSCAPE ARCHITECTS
210 La Veta Drive NE
Albuquerque, New Mexico 87108
505-268-2266

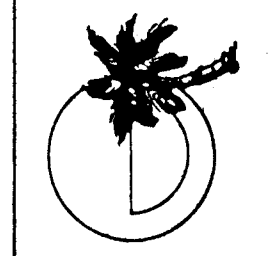

NOVEMBER
1986

AS BUILT

WEST MESA WELL #4
7721 SARRACINO PLACE NW
IRRIGATION PLAN

LANDSCAPING IMPROVEMENTS FOR
WATER SYSTEM FACILITY SITES
WATER SYSTEMS DIVISION
CITY OF ALBUQUERQUE
ALBUQUERQUE, NEW MEXICO

SHEET
12

1	2	3	100
---	---	---	---	---	---	---	---	---	----	----	-----

NOTE: POND IS NOT WATER UTILITIES DEPT. PROPERTY

RIP RAP

DIRT ACCESS ROAD

CONCRETE

LOW JAP 'HAL' (10)
PAR QUL (5)

LOW JAP 'HAL' (25)
PAR QUL (12)

LOW JAP 'HAL' (7)
PAR QUL (3)

WELL #4

DRY WELL

ROB PSE (3)
(15 GAL.)

SARRACINO PLACE

Pin ELD (3)
(15 GAL.)

The site plan shows a property layout with several water-related features. A central area contains 'WELL #4' and a 'DRY WELL'. To the left, a 'DIRT ACCESS ROAD' leads from a 'RIP RAP' area. The property is bordered by 'SARRACINO PLACE' at the bottom. Various water features are labeled with handwritten notes: 'LOW JAP 'HAL' (10) PAR QUL (5)', 'LOW JAP 'HAL' (25) PAR QUL (12)', 'LOW JAP 'HAL' (7) PAR QUL (3)', 'PIN ELD (3) (15 GAL.)', and 'ROB PSE (3) (15 GAL.)'. A circular feature is labeled 'L 170'. The plan also shows a 'CONCRETE' area and a 'RIP RAP' area.


① L
170

① L
170

PIN ELB (3)
(15 GAL.)

$\frac{L}{170}$

MORROW & COMPANY
LANDSCAPE ARCHITECTS
210 La Veta Drive NE
Albuquerque, New Mexico 87108
505-268-2266

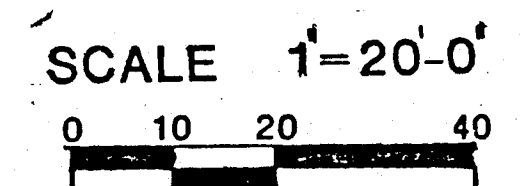

26 309713786



- BENCHMARK:
 □ CUT IN TOP OF CURB
 ELEV. 5067.36

- FINISH GRADE OF ASPHALT SHALL MATCH FINISH GRADE OF DRIVE PAD EDGE.


EXISTING ROCK

5068
5069
5070
5071
5072
5073
5074
5075
5076
5077
5078

HAZELDINE AVE. SE.

SPRUCE ST. SE.

SCALE 1"=20'-0"

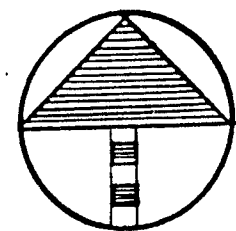

26 309713886

SHEET
166
OF
172


LANDSCAPING IMPROVEMENTS FOR
WATER SYSTEM FACILITY SITES
WATER SYSTEMS DIVISION
CITY OF ALBUQUERQUE
ALBUQUERQUE, NEW MEXICO


YALE WELL #3
1220 HAZELDINE AVE. SE
GRADING PLAN

AS BUILT


NOVEMBER
1986

MORROW & COMPANY
LANDSCAPE ARCHITECTS
210 La Veta Drive NE
Albuquerque, New Mexico 87108
505-268-2266

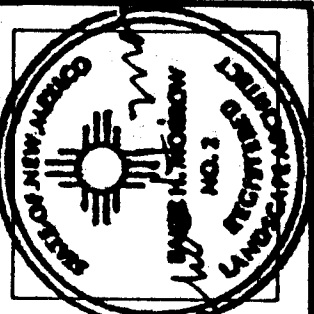

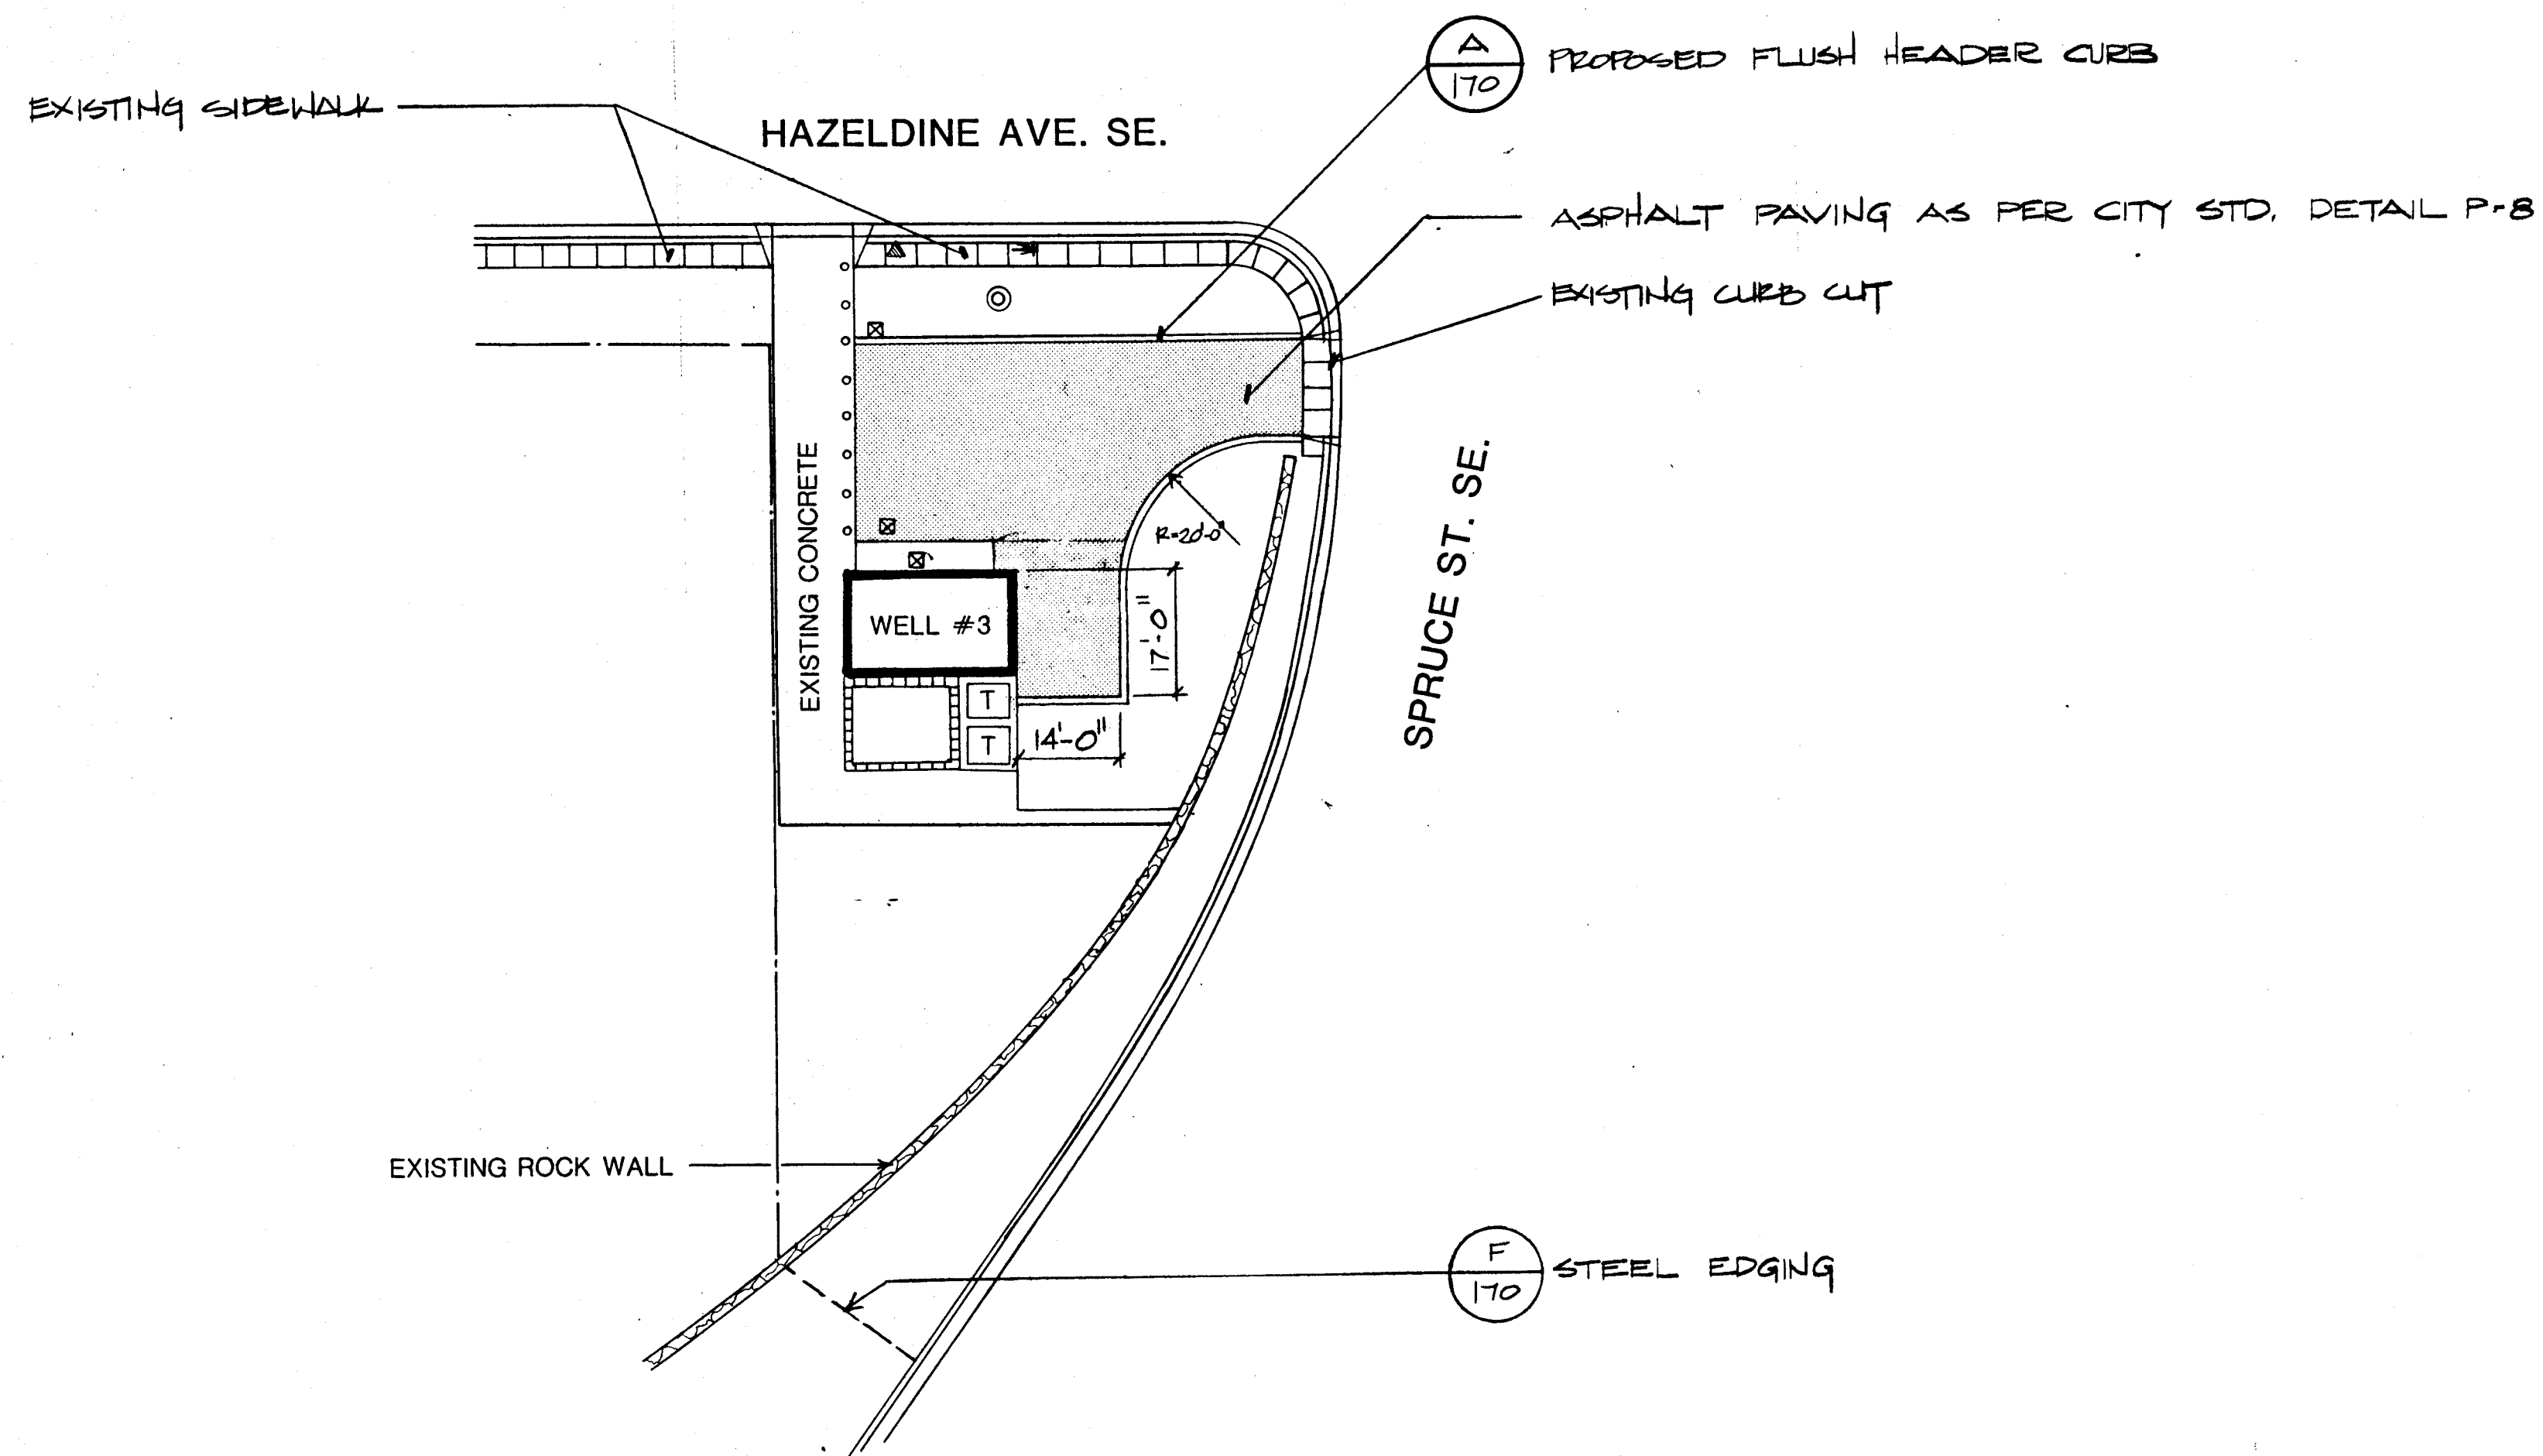

SCALE 1"=20'-0"

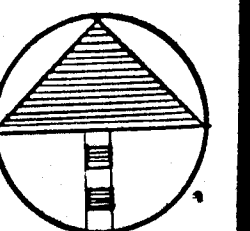

26 309.713986

MORROW & COMPANY
LANDSCAPE ARCHITECTS
210 La Veta Drive NE
Albuquerque, New Mexico 87108
505-268-2266




NOVEMBER
1986

AS BUILT

YALE WELL #3
1220 HAZELDINE AVE. SE
CONSTRUCTION PLAN

LANDSCAPING IMPROVEMENTS FOR
WATER SYSTEM FACILITY SITES
WATER SYSTEMS DIVISION
CITY OF ALBUQUERQUE
ALBUQUERQUE, NEW MEXICO

SHEET
161
09
12

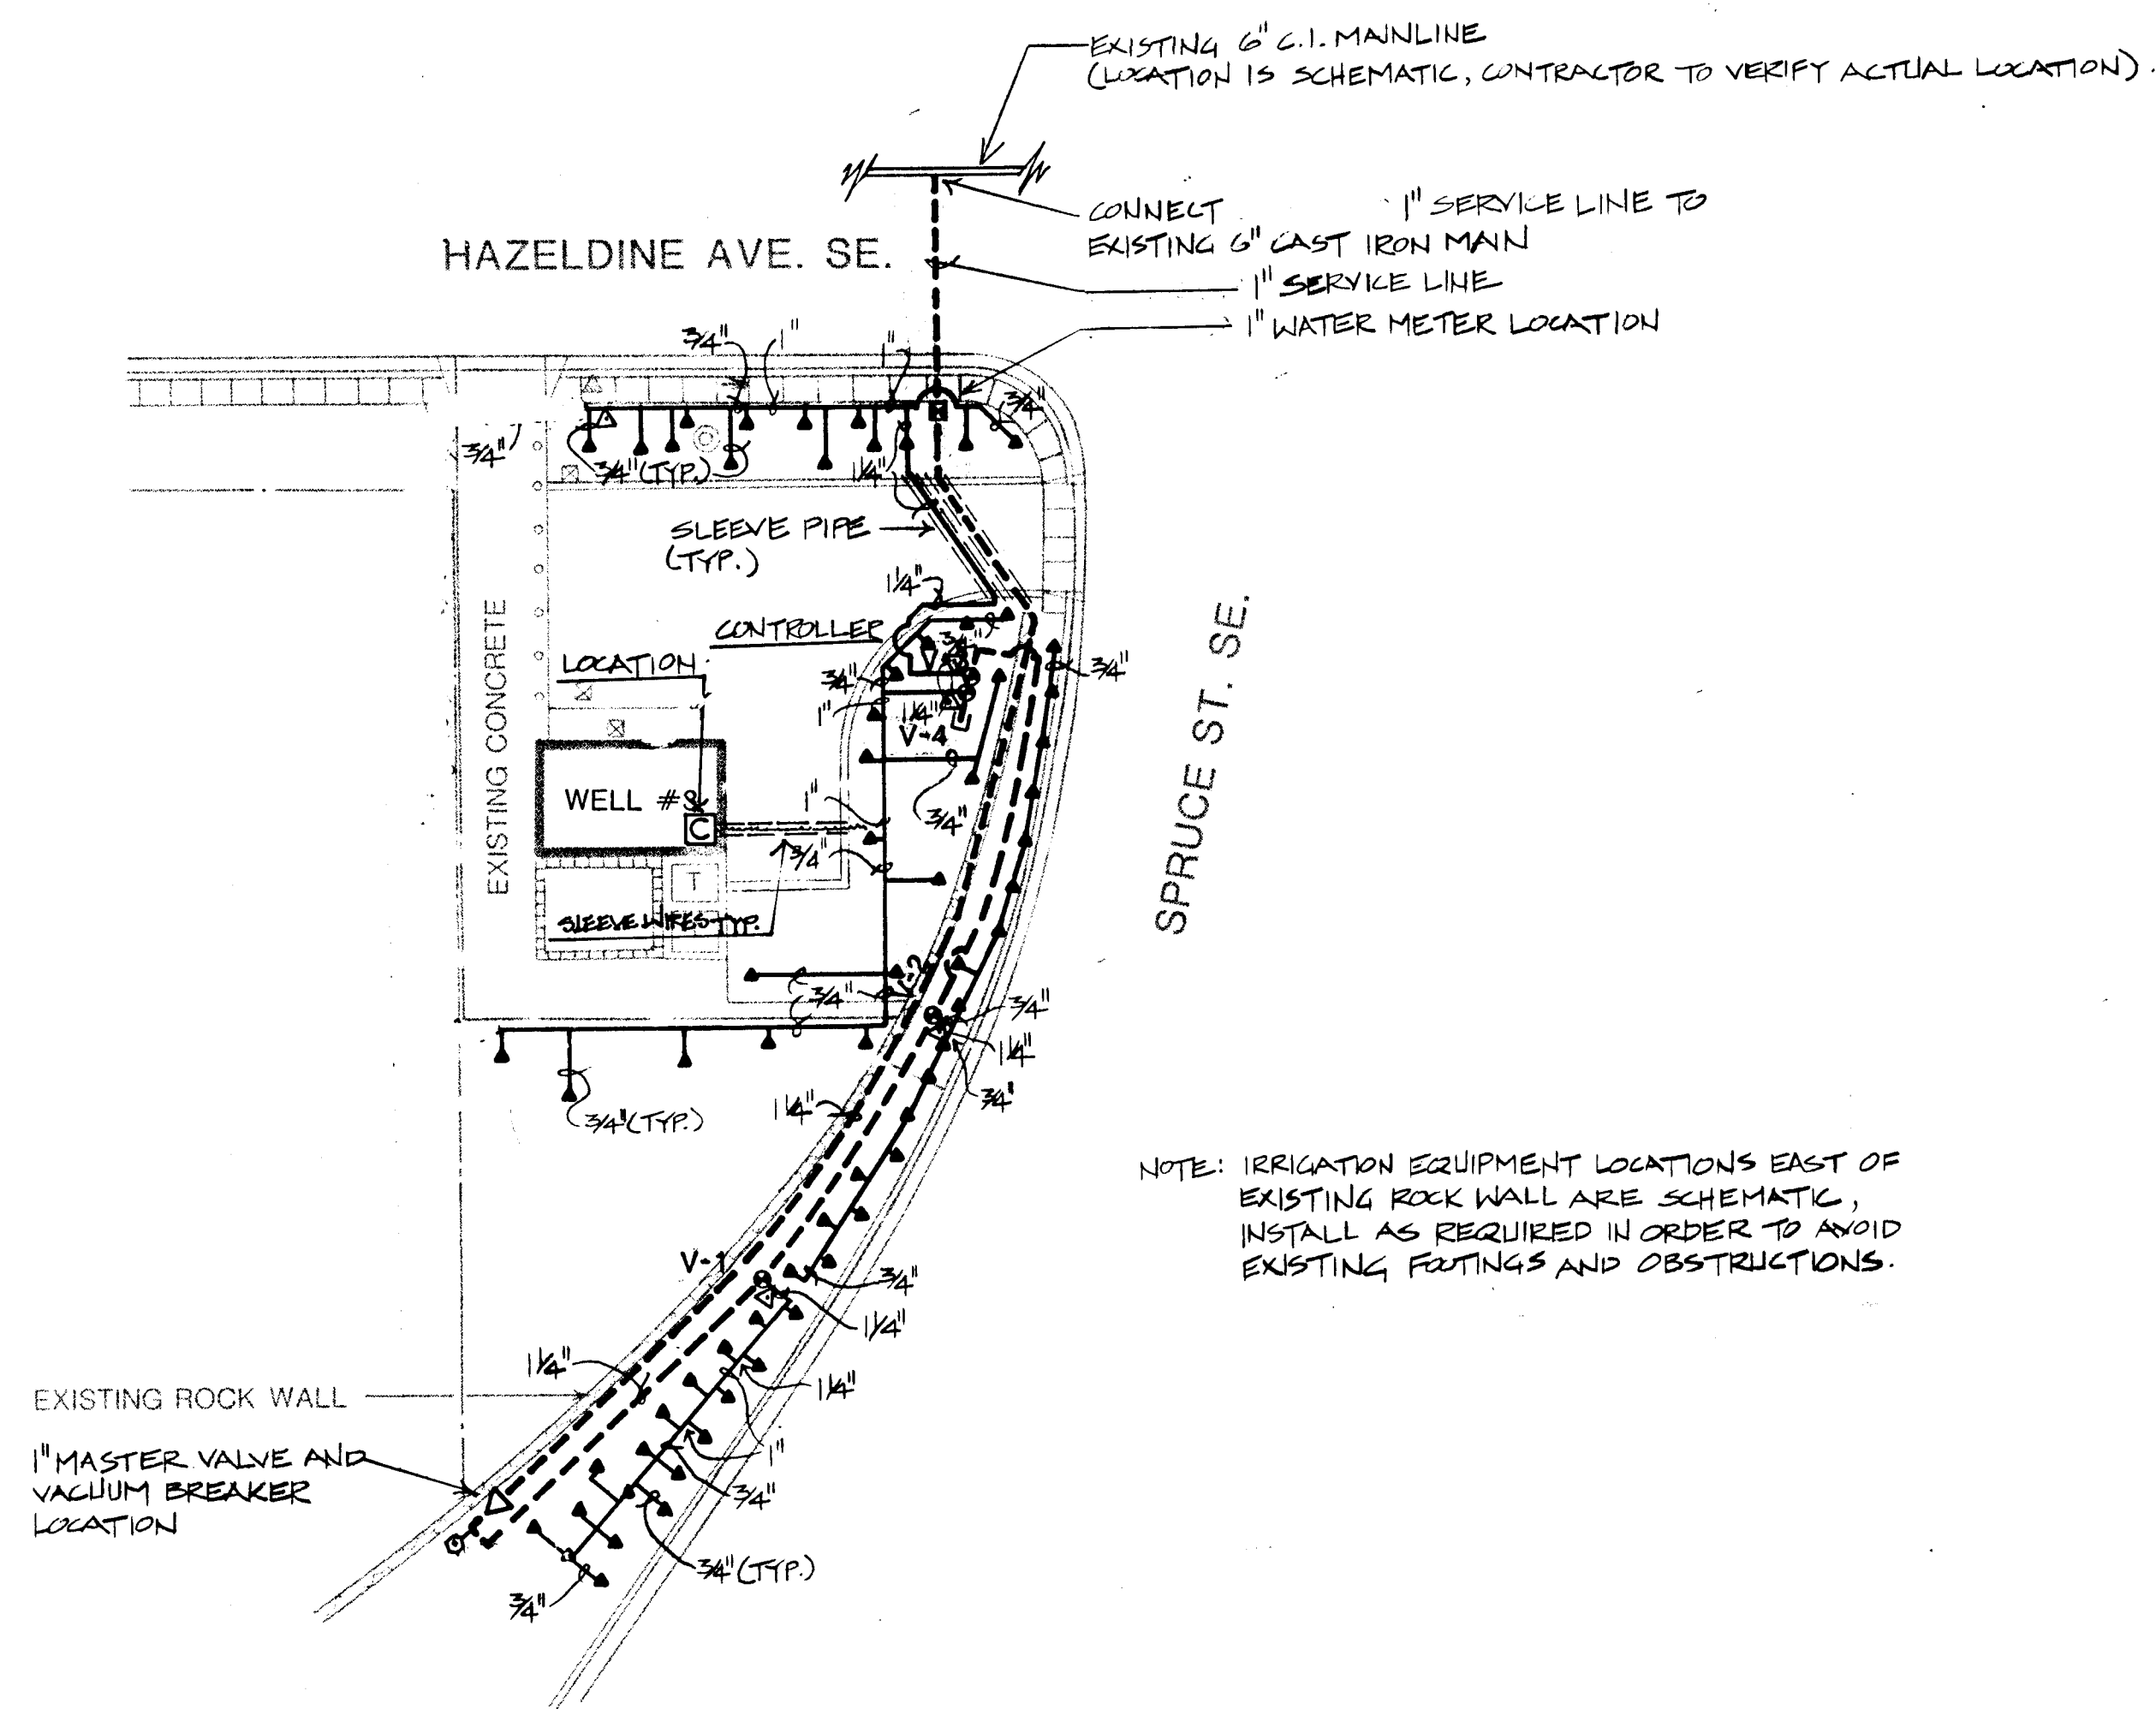


ELECTRICAL PANEL → ← IRRIGATION CONTROLLER

CIRCUIT #1


3/4" RIGID STEEL CONDUIT, 110 VOLT ELECTRICAL
 1/2" RIGID STEEL CONDUIT, 24 VOLT CIRCUIT
 TO REMOTE CONTROL VALVES

SCHEMATIC ASBUILT FOR 110 VOLT ELECTRICAL
 FROM SOURCE TO IRRIGATION CONTROLLER


SCALE 1"=20'-0"
 0 10 20 40

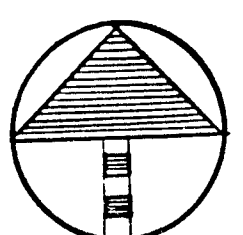

26 309714086

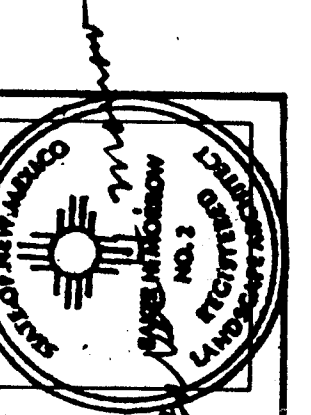

MORROW & COMPANY
 LANDSCAPE ARCHITECTS
 210 La Veta Drive NE
 Albuquerque, New Mexico 87108
 505-268-2266

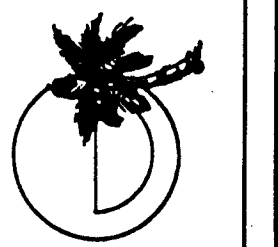


NOVEMBER
 1986

AS BUILT

YALE WELL #3
 1220 HAZELDINE AVE. SE
IRRIGATION PLAN

LANDSCAPING IMPROVEMENTS FOR
WATER SYSTEM FACILITY SITES
 WATER SYSTEMS DIVISION
 CITY OF ALBUQUERQUE
 ALBUQUERQUE, NEW MEXICO


SHEET
 10
 2

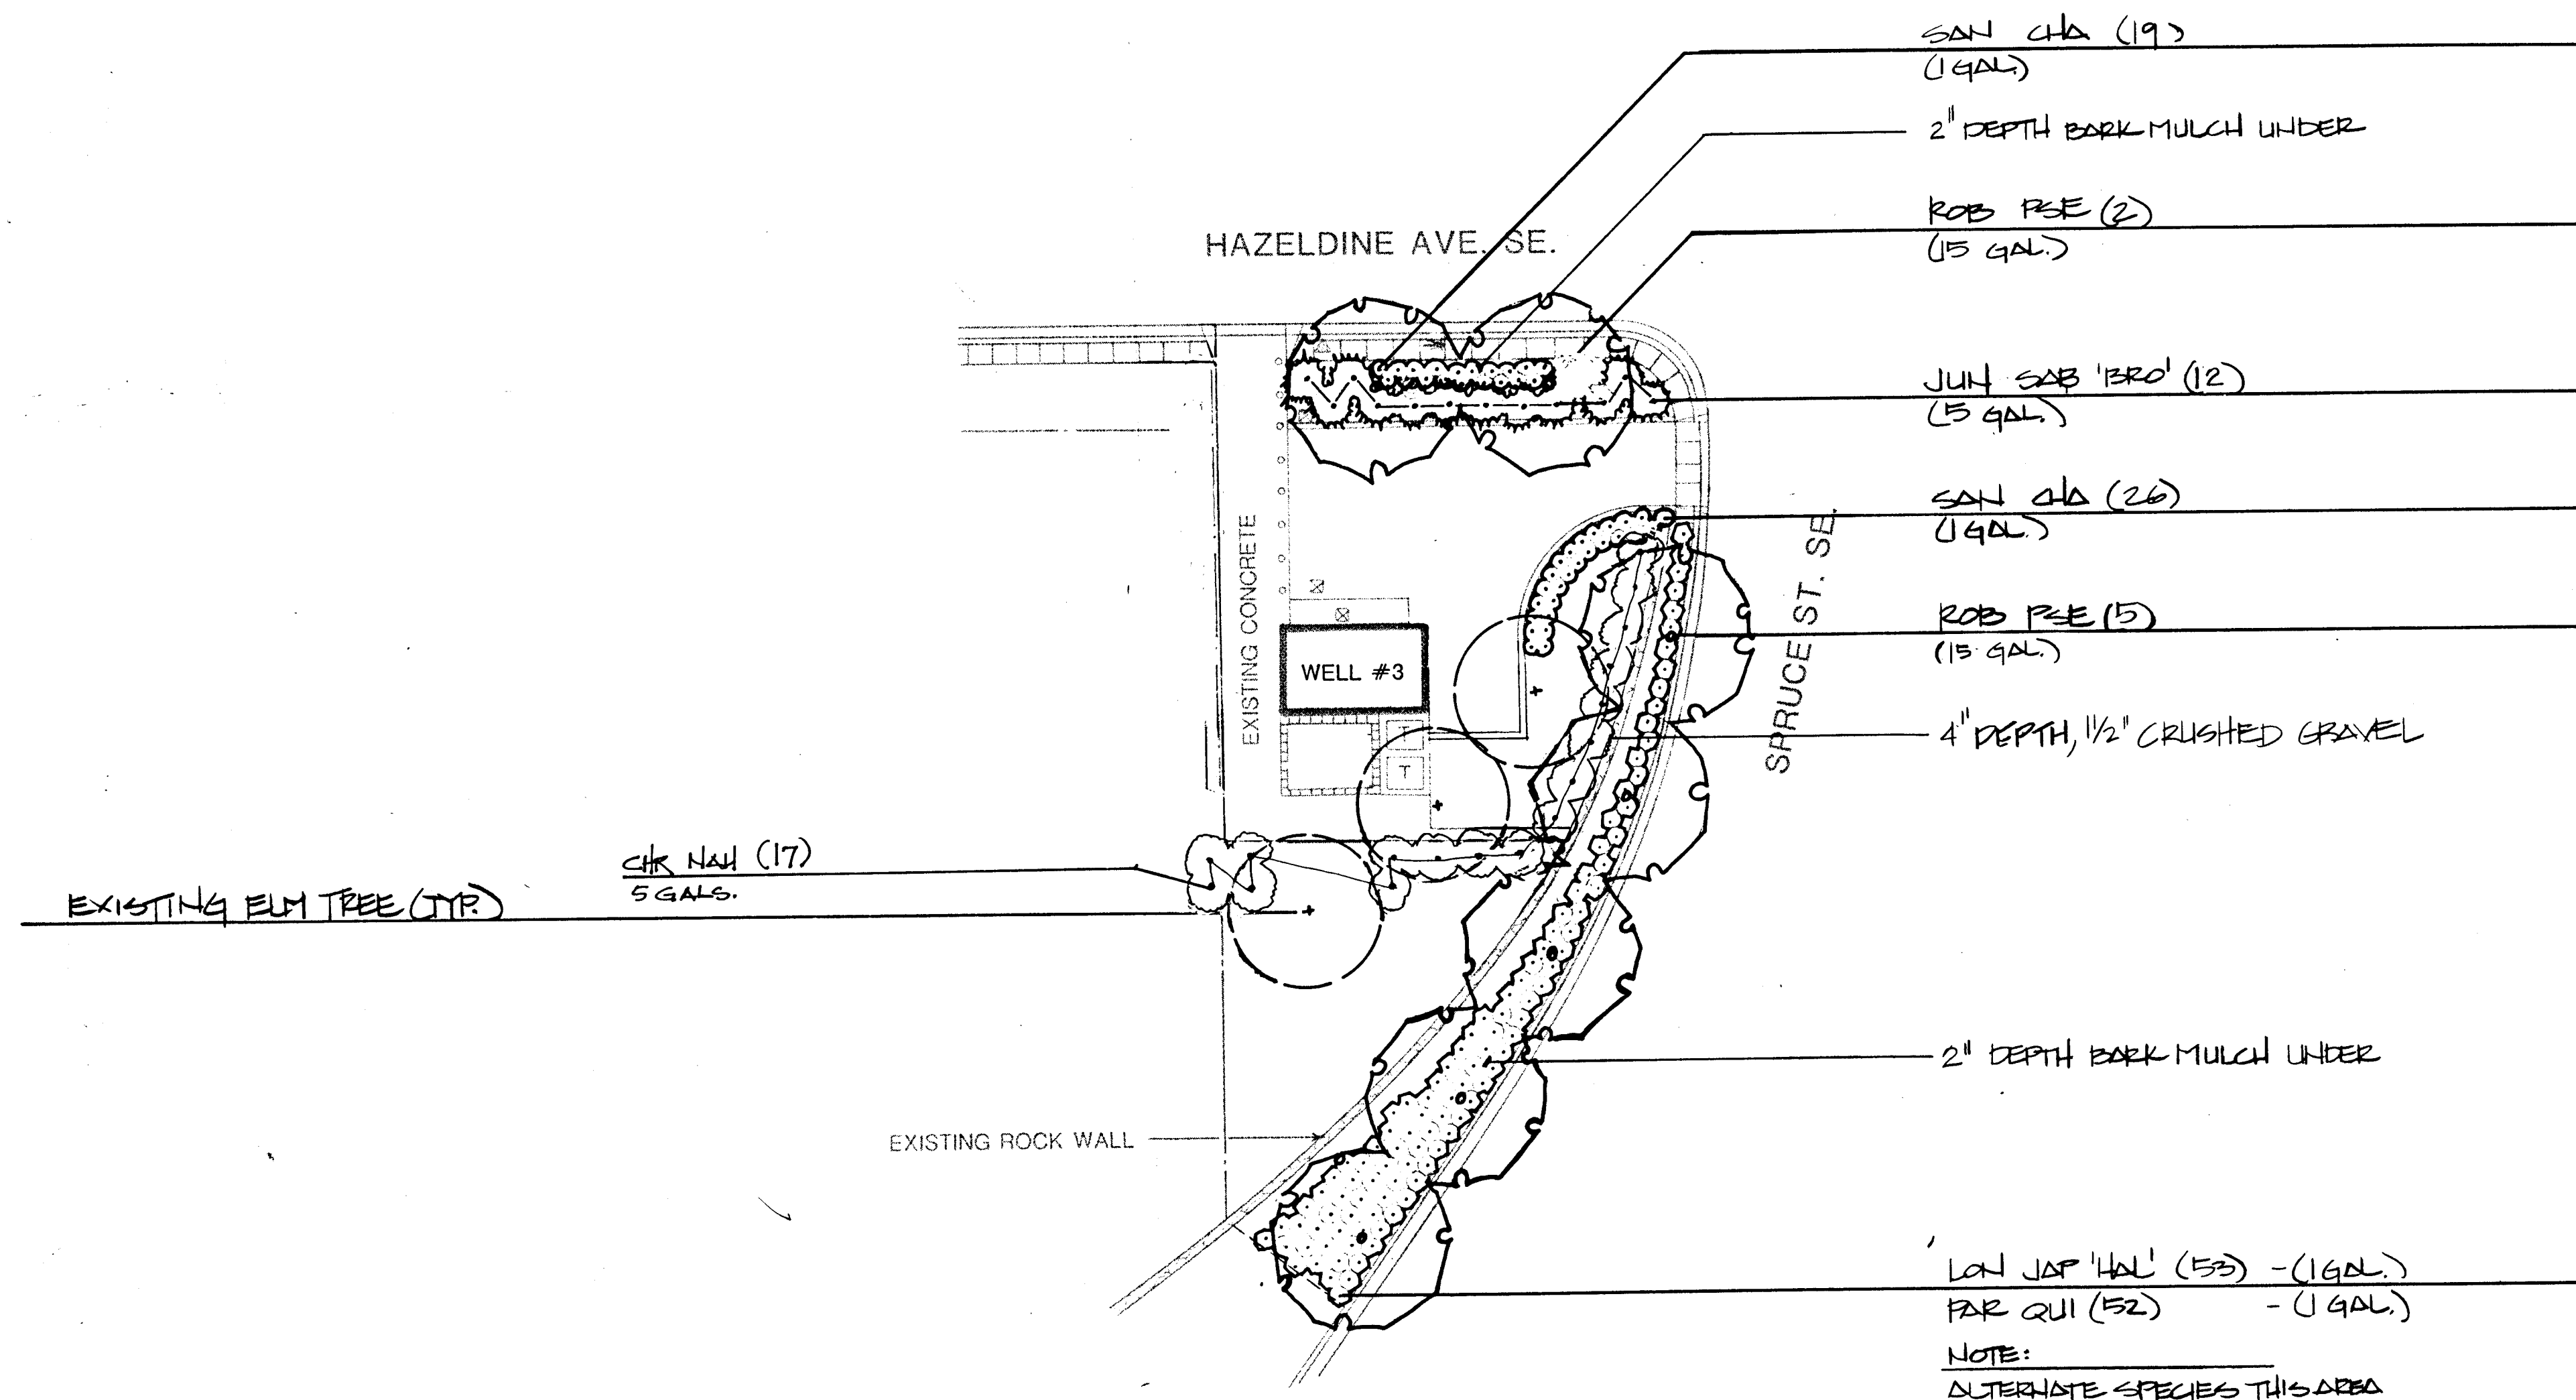

SCALE 1"=20'-0"

0 10 20 40

26 309714186

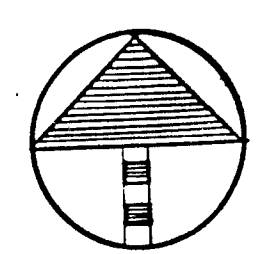

LANDSCAPING IMPROVEMENTS FOR
WATER SYSTEM FACILITY SITES
WATER SYSTEMS DIVISION
CITY OF ALBUQUERQUE
ALBUQUERQUE, NEW MEXICO





SHEET
169
OF
172

YALE WELL #3
1220 HAZELDINE AVE. SE
PLANTING PLAN





AS BUILT

NOVEMBER
1986





MORROW & COMPANY
LANDSCAPE ARCHITECTS
210 La Veta Drive NE
Albuquerque, New Mexico 87108
505-268-2266

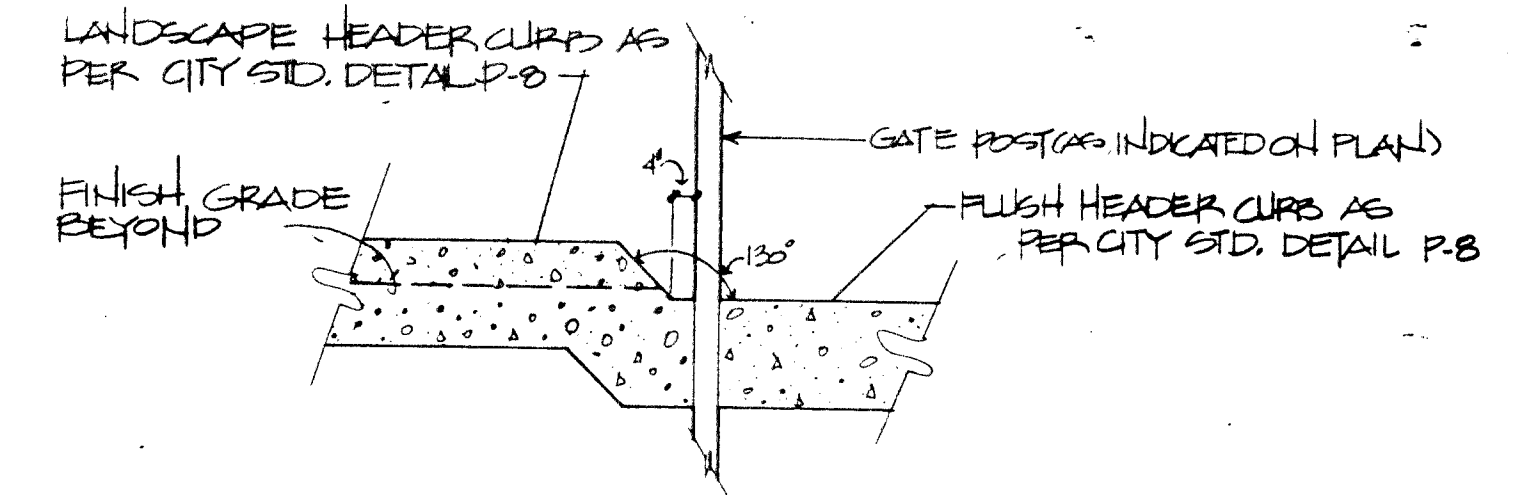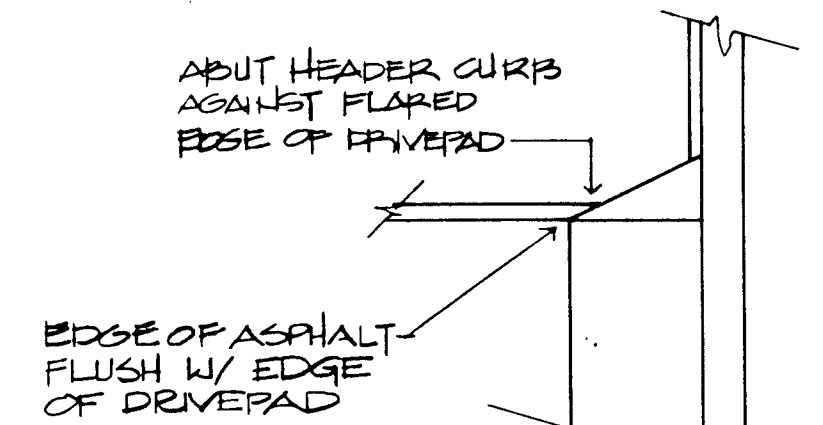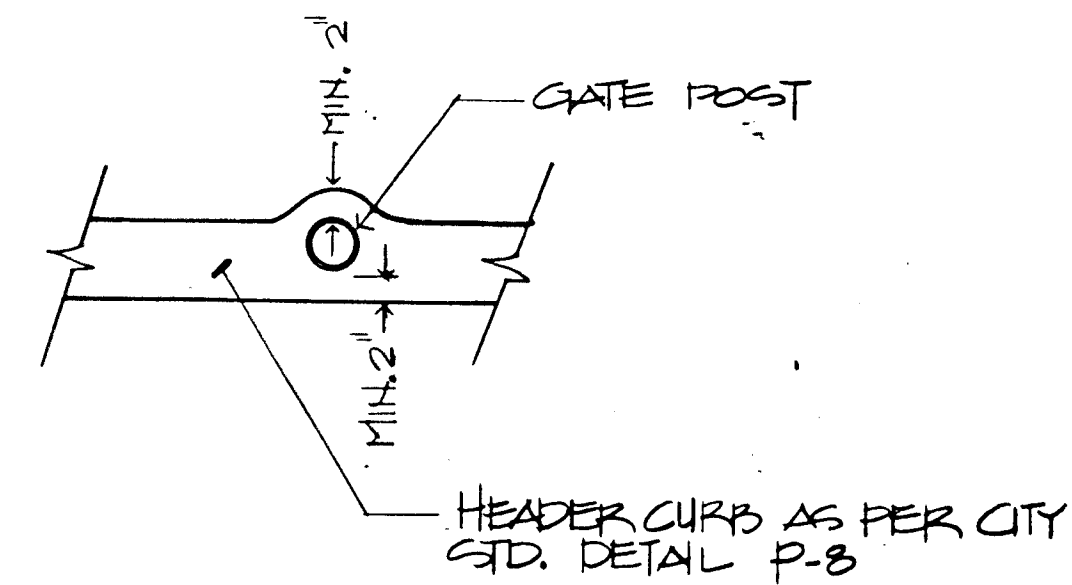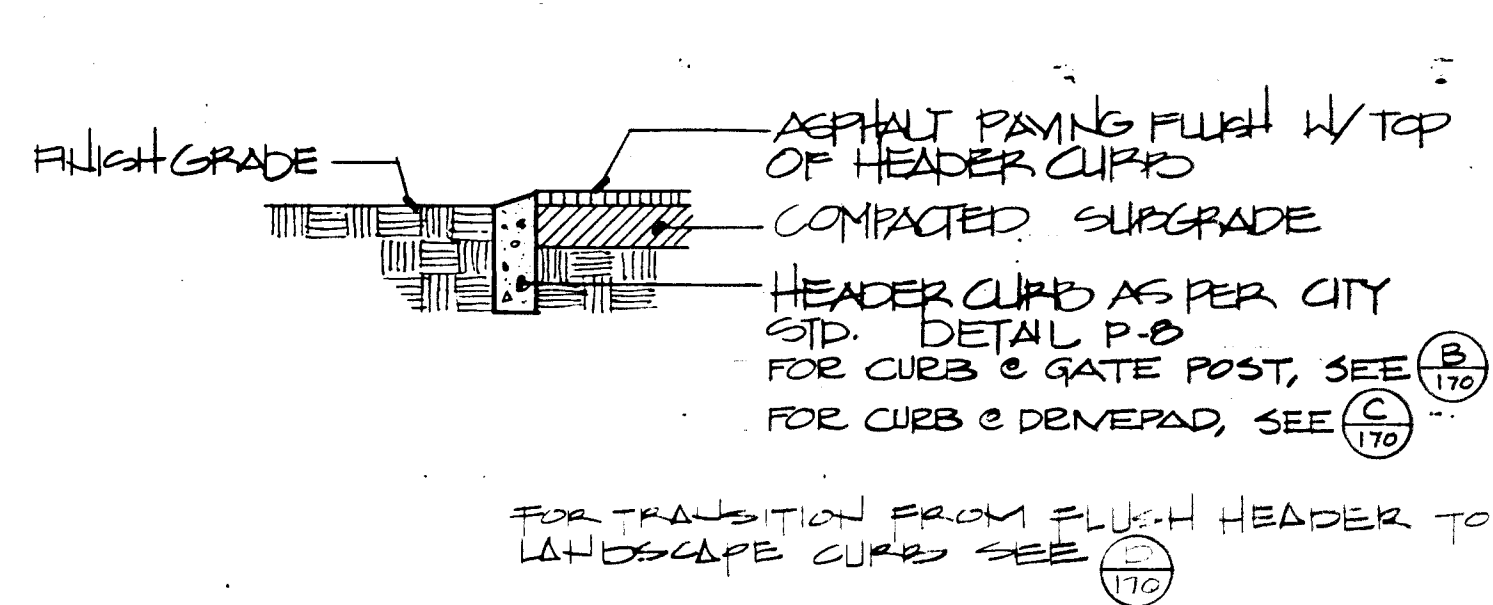





(A) FLUSH HEADER CURB N.T.S. (B) FLUSH HEADER CURB @ GATE POST N.T.S. (C) ASPHALT PAVING @ HEADER CURB @ DRIVEPAD N.T.S. (D) TRANSITION: FLUSH CURB TO LANDSCAPE CURB N.T.S.

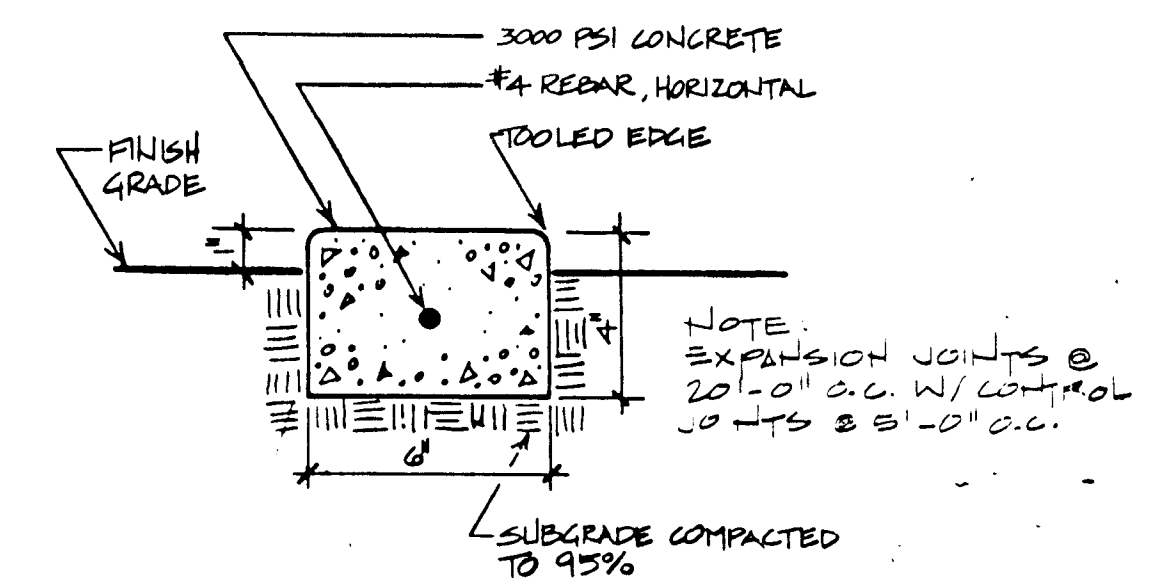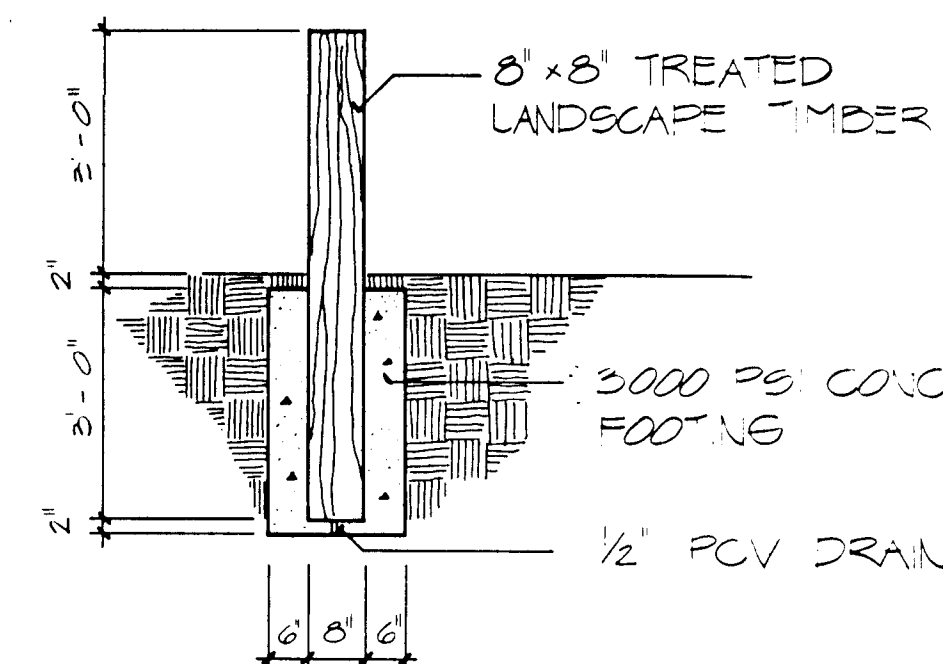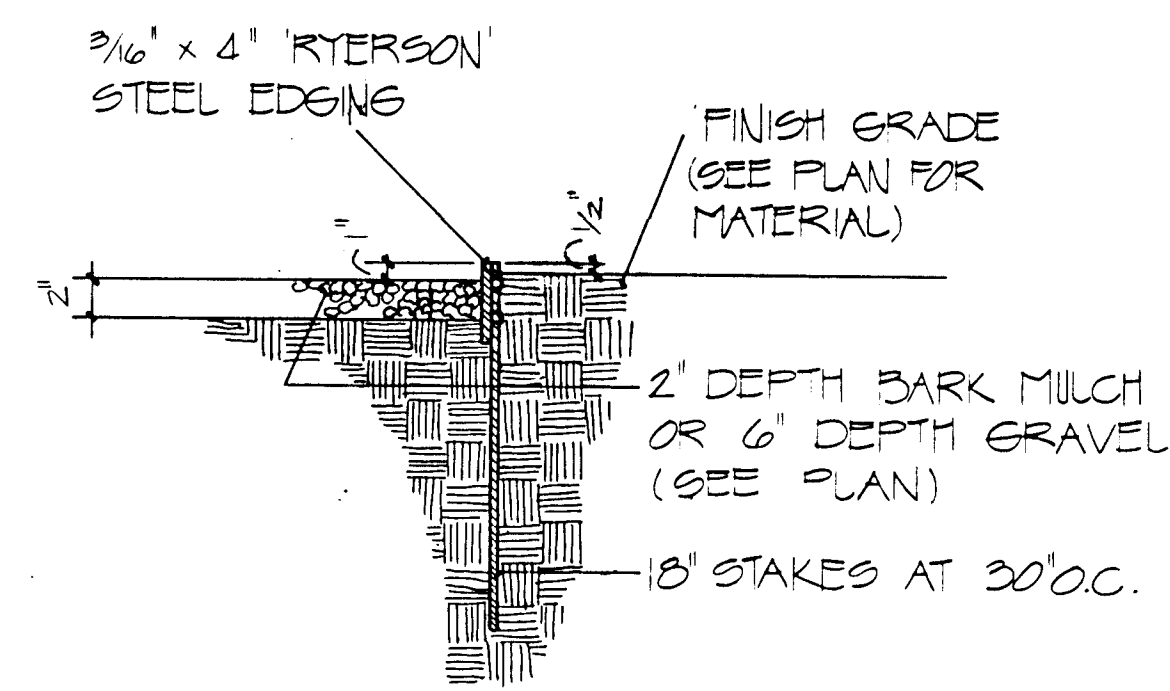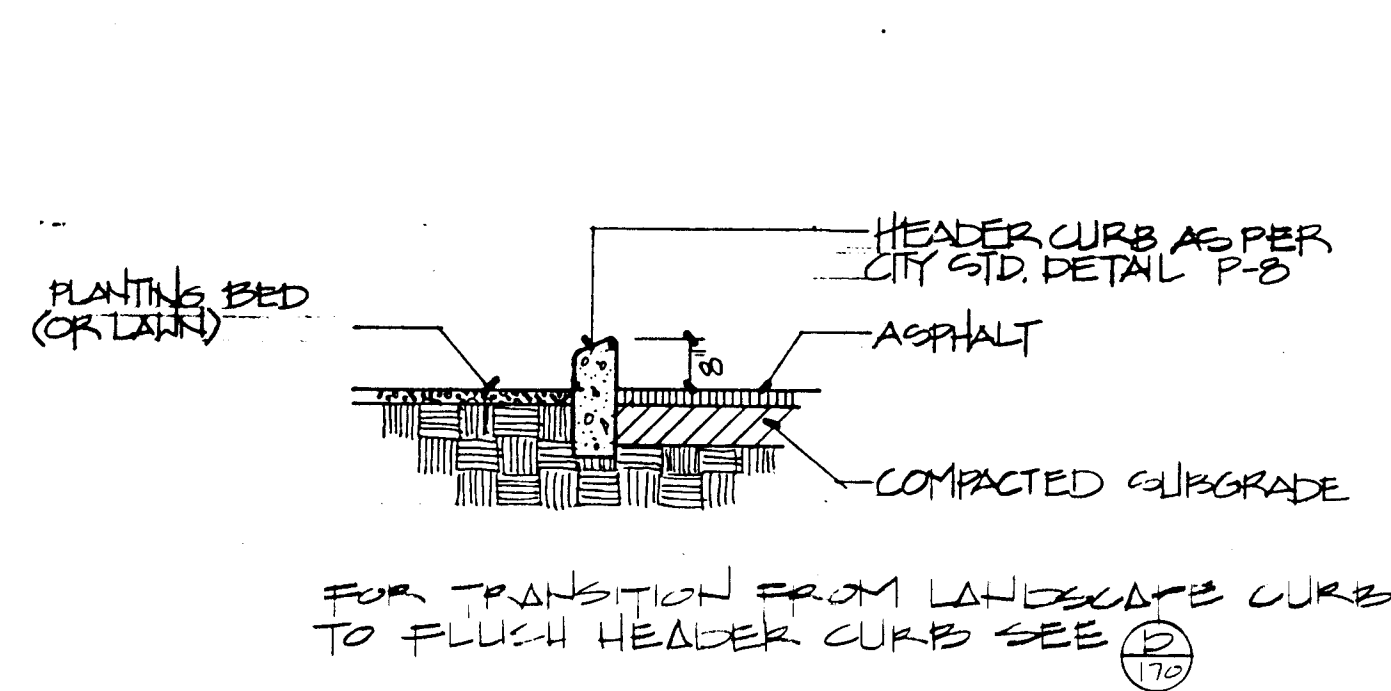

(E) LANDSCAPE HEADER CURB N.T.S. (F) STEEL EDGING N.T.S. (G) BOLLARD N.T.S. (H) MOWSTRIP N.T.S.

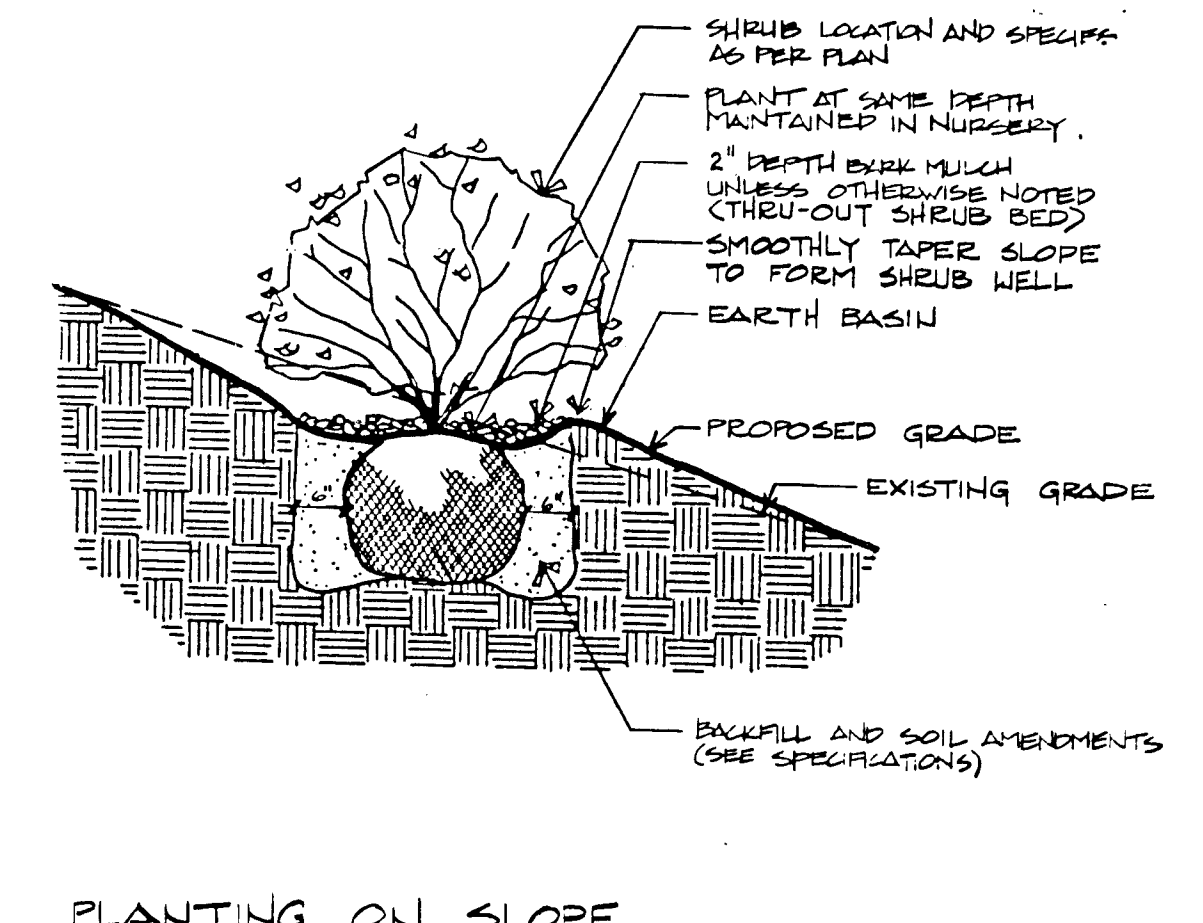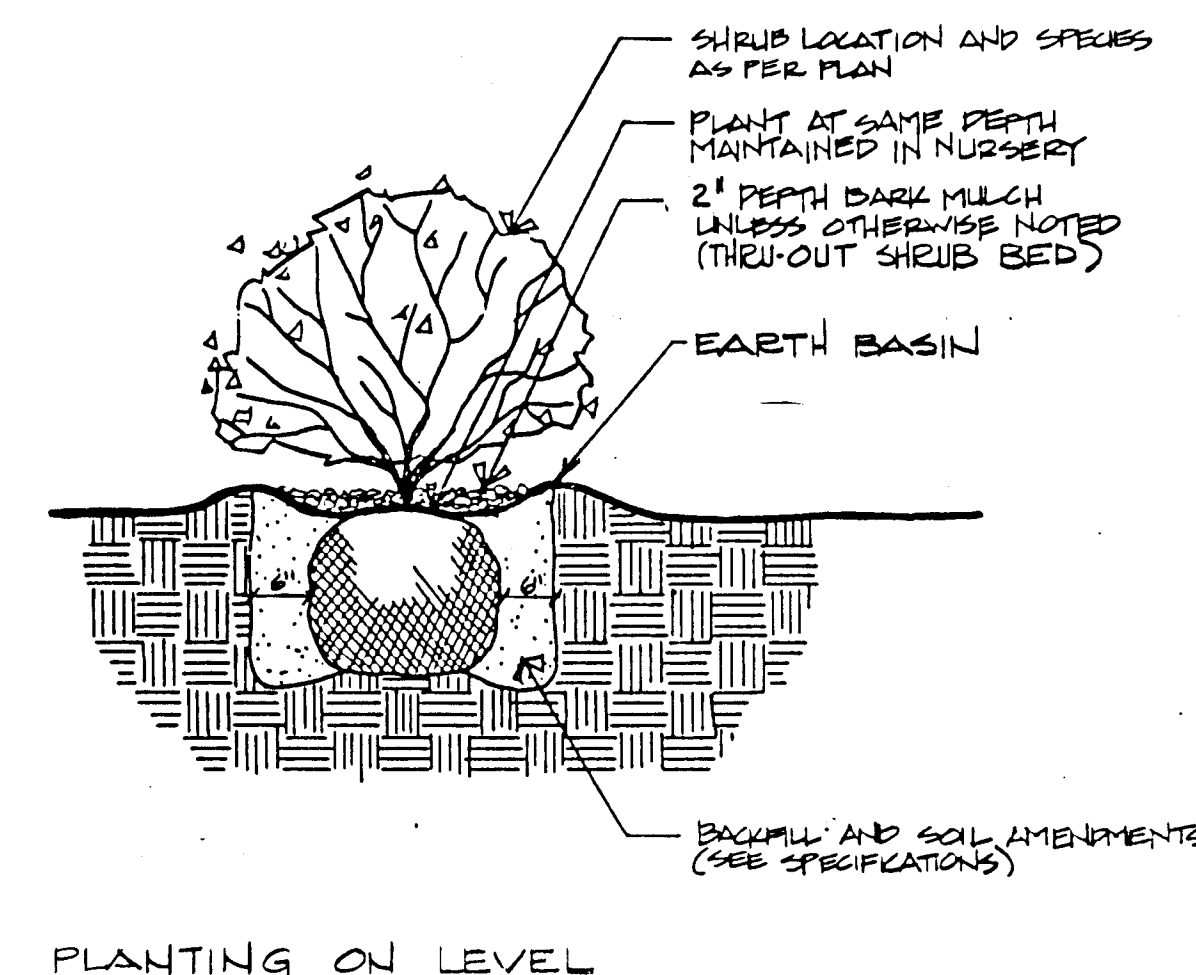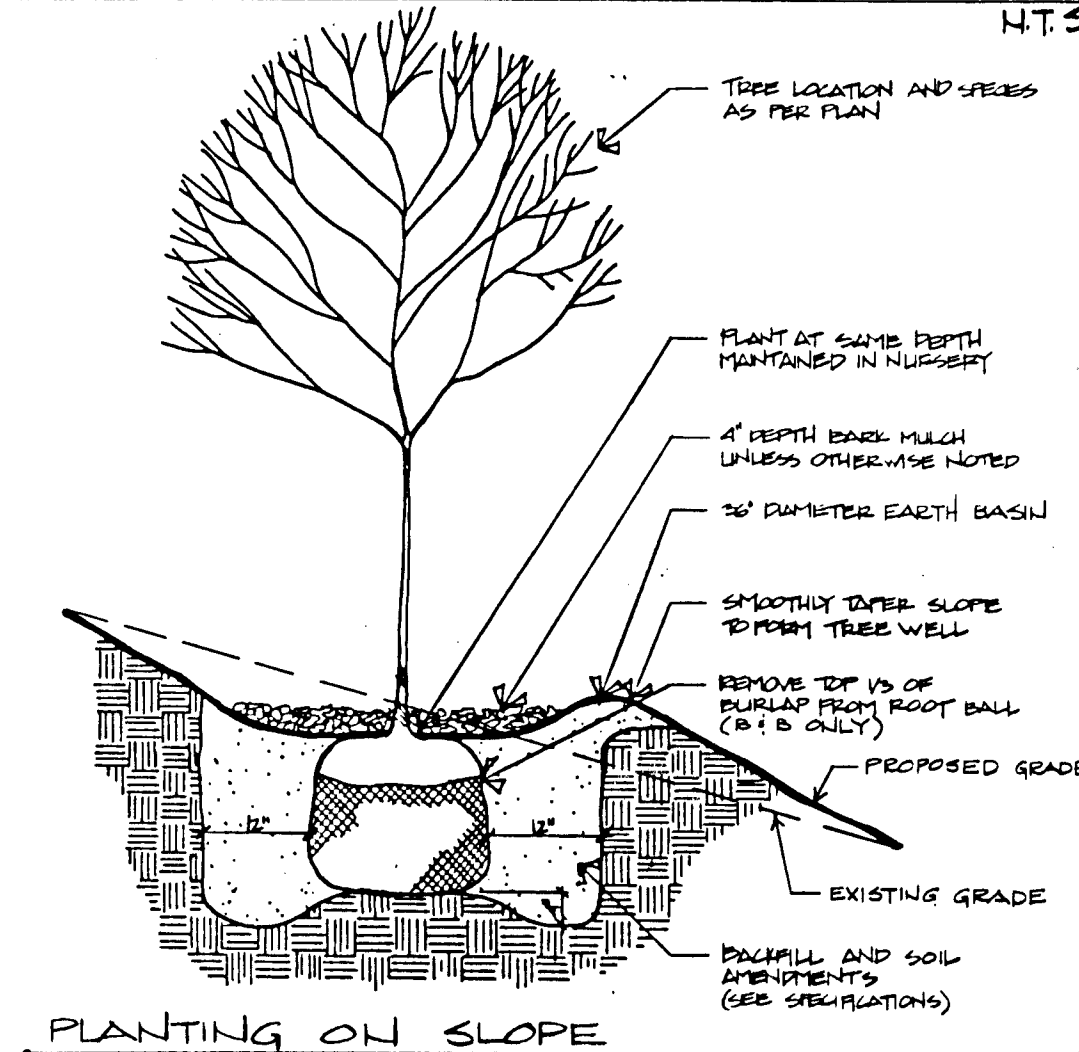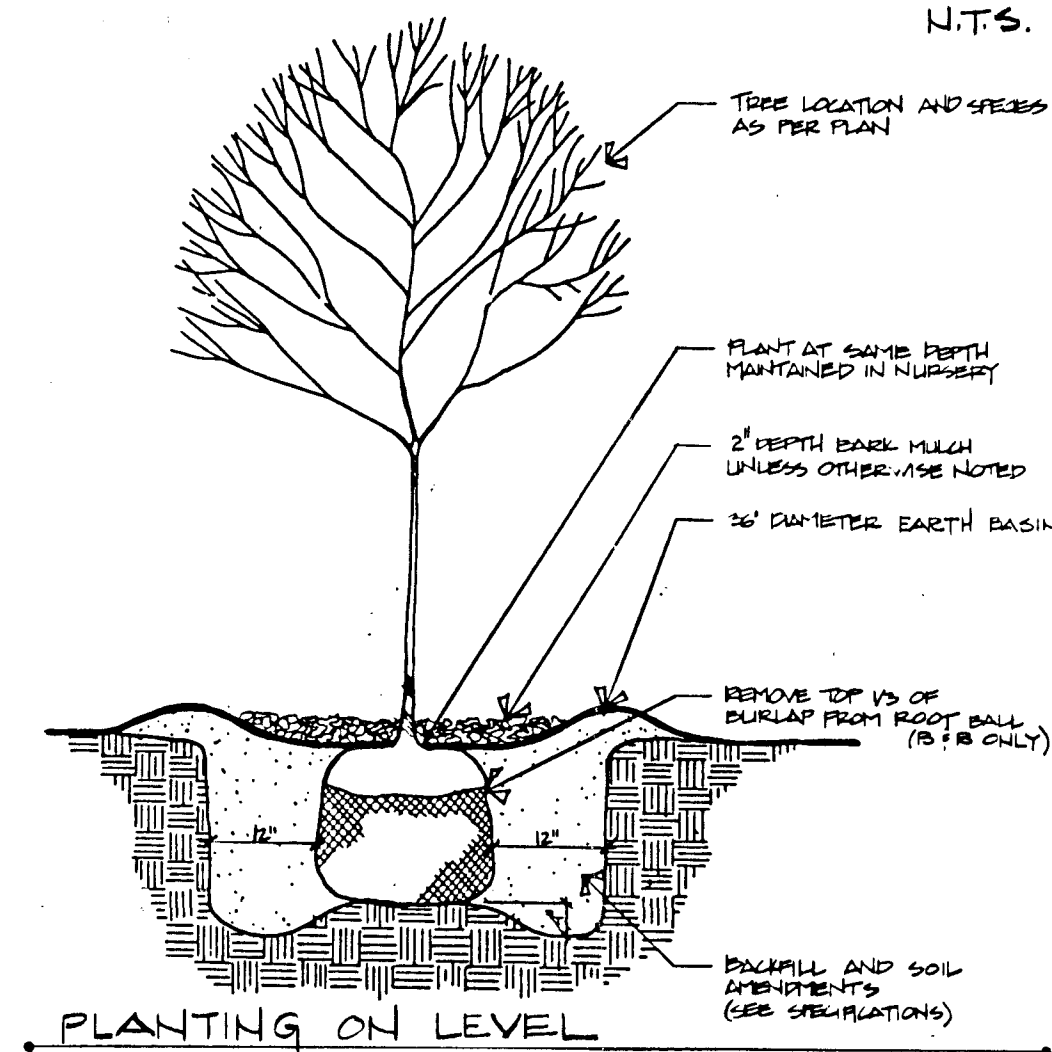

(I) TREE PLANTING N.T.S. (J) TREE PLANTING N.T.S. (K) SHRUB PLANTING N.T.S. (L) SHRUB PLANTING N.T.S.

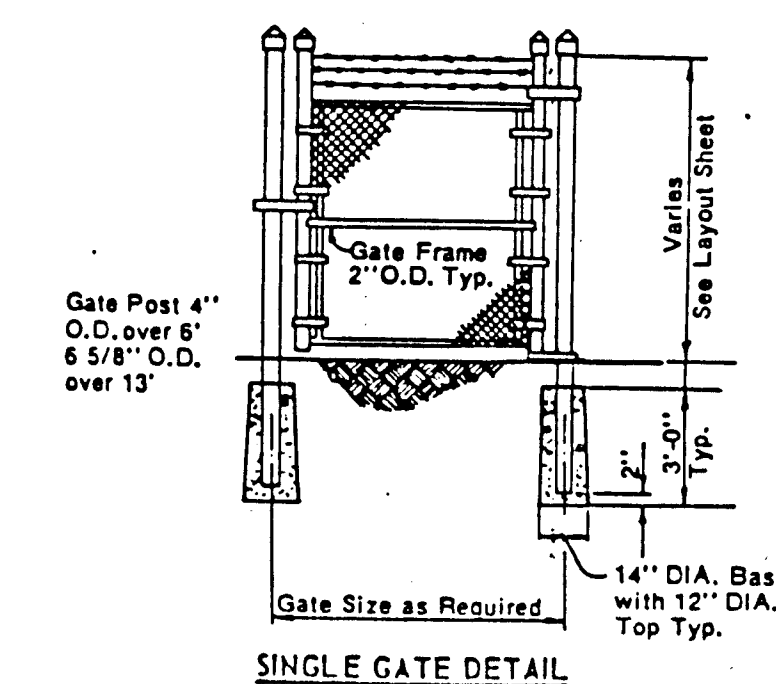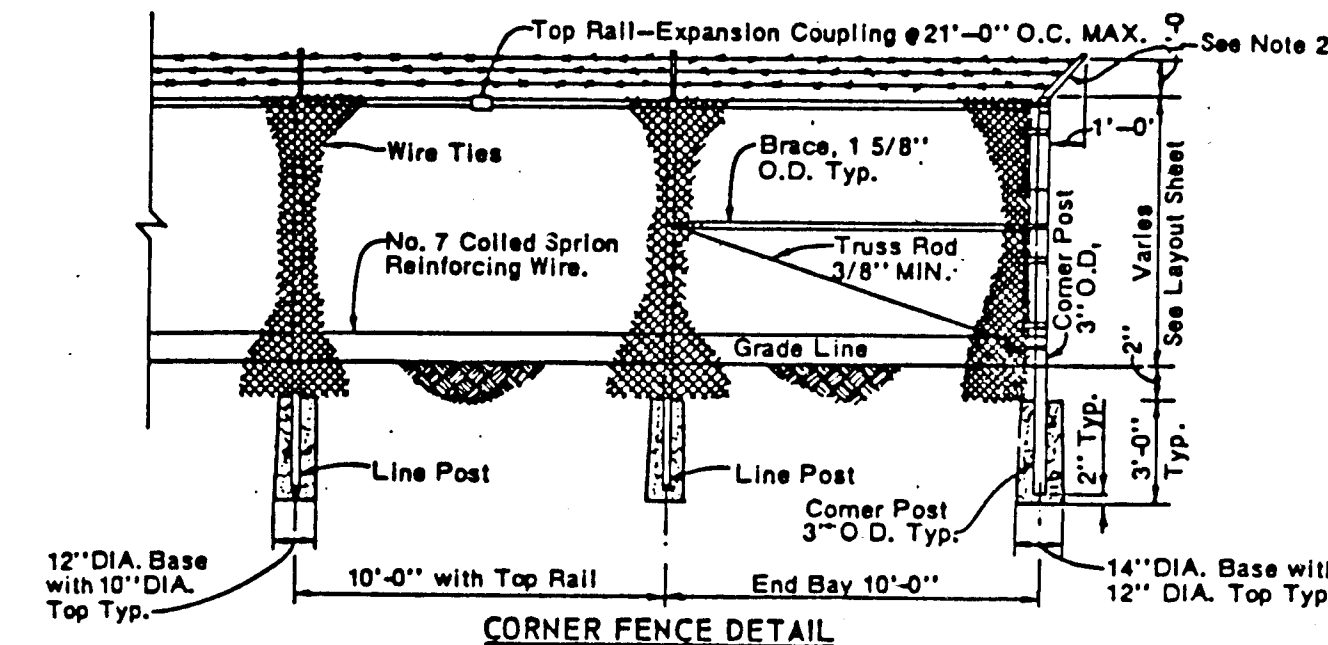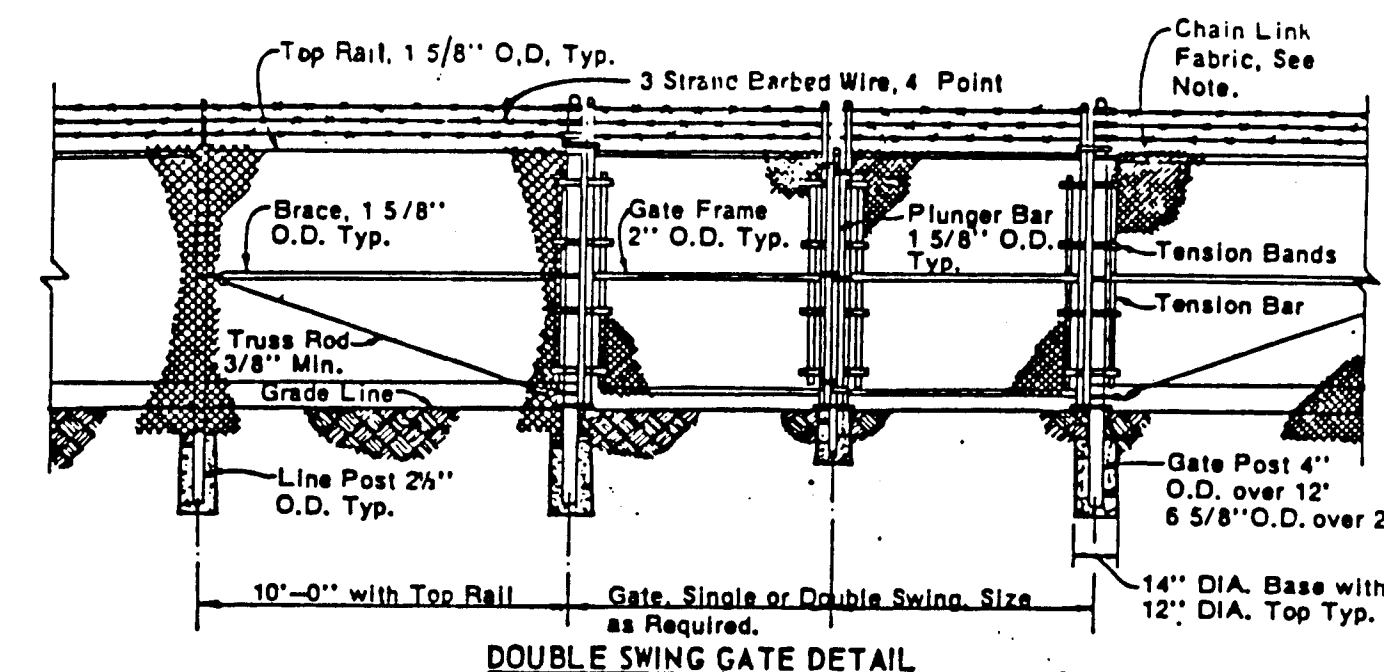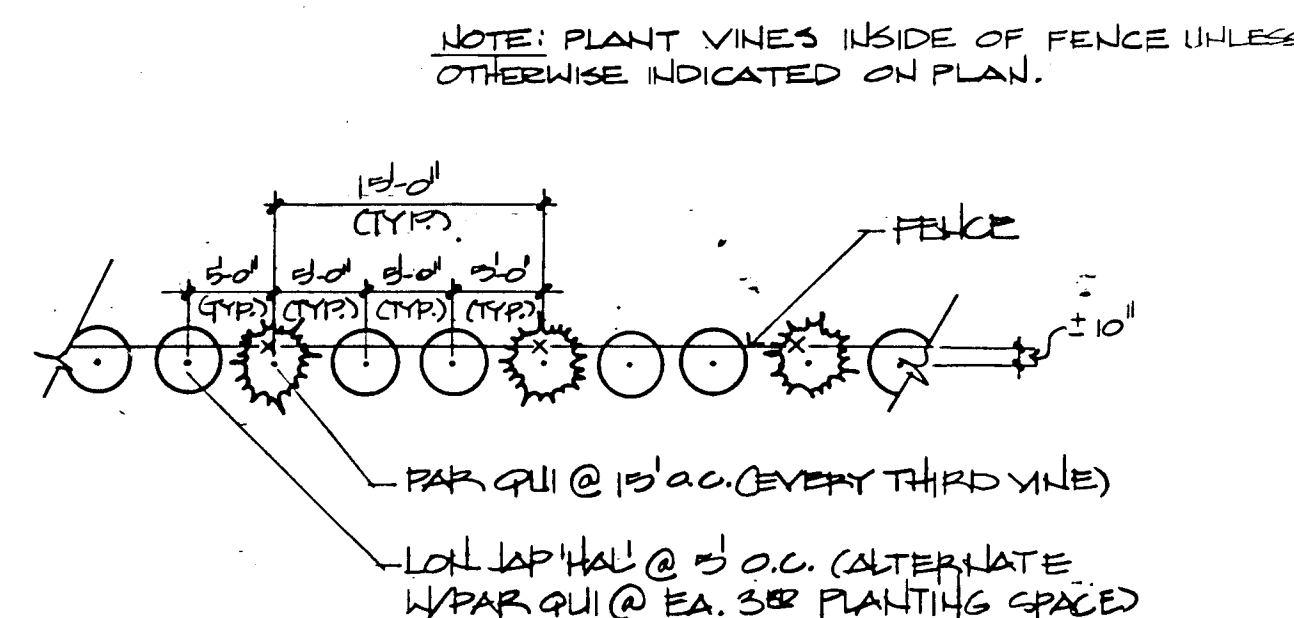


NOTE:


1. All fabric to be #9 gage wire, woven in a 2" mesh top and bottom edges to be twisted.
2. Single extension arms shall point outward at an angle of 45° with 3 strands of 4 point barbed wire securely attached to extension arm along top of fence, top strand to be 1'-0" above top rail. Extension arms to be 12 gage pressed steel.
3. Fence to be Realock 423 or equal.

(M) CHAIN LINK FENCE N.T.S. (N) DOUBLE SWING GATE DETAIL N.T.S. (O) CORNER FENCE DETAIL N.T.S. (P) SINGLE GATE DETAIL N.T.S.

26. 309714286

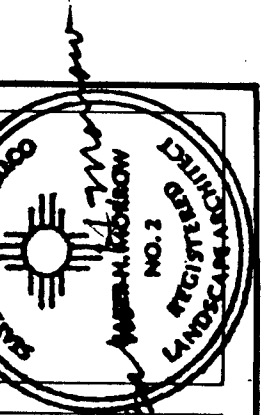

MORROW & COMPANY
LANDSCAPE ARCHITECTS
210 La Veta Drive NE
Albuquerque, New Mexico 87108
505-268-2266






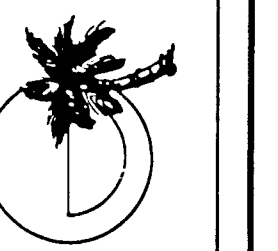



NOVEMBER 1986

DETAILS **AS BUILT**


LANDSCAPING IMPROVEMENTS FOR
WATER SYSTEM FACILITY SITES
WATER SYSTEMS DIVISION
CITY OF ALBUQUERQUE
ALBUQUERQUE, NEW MEXICO

SHEET
170
OF
172

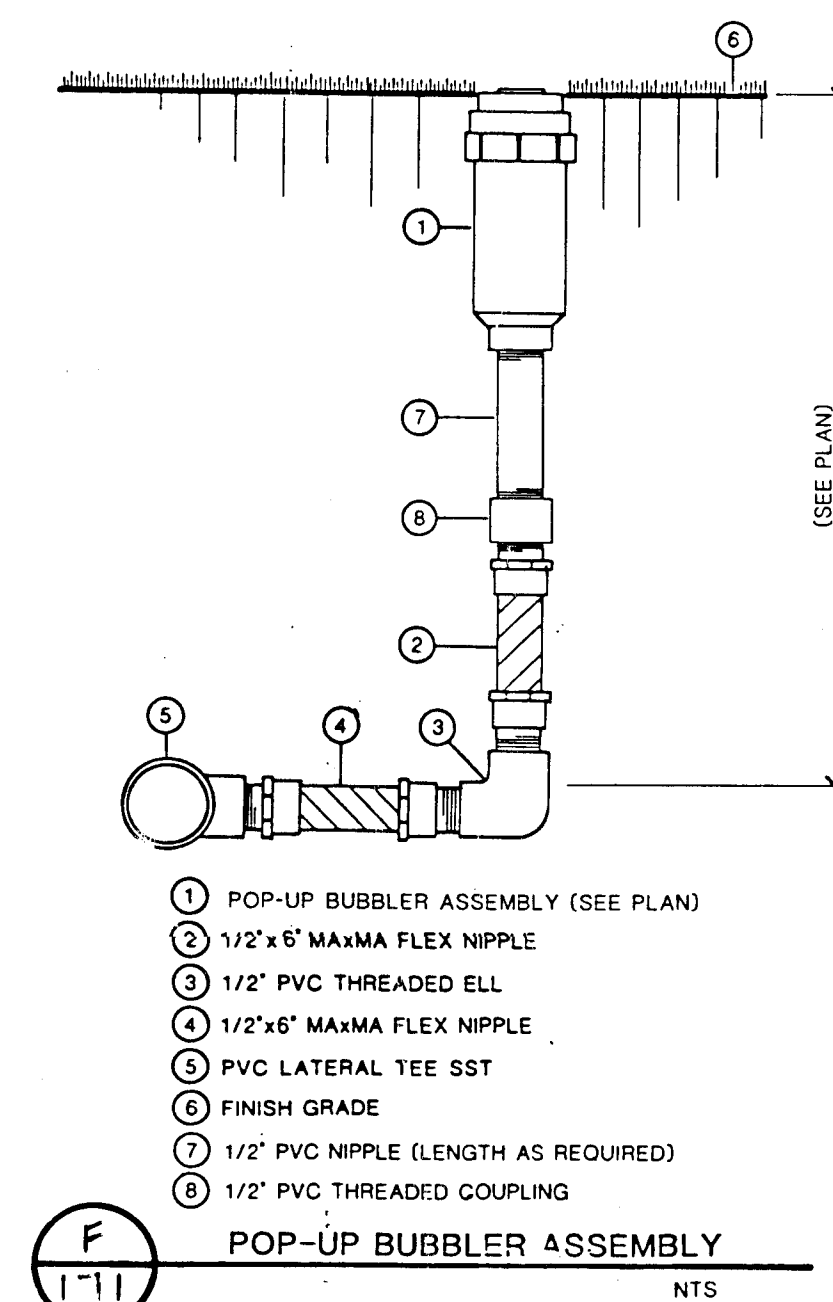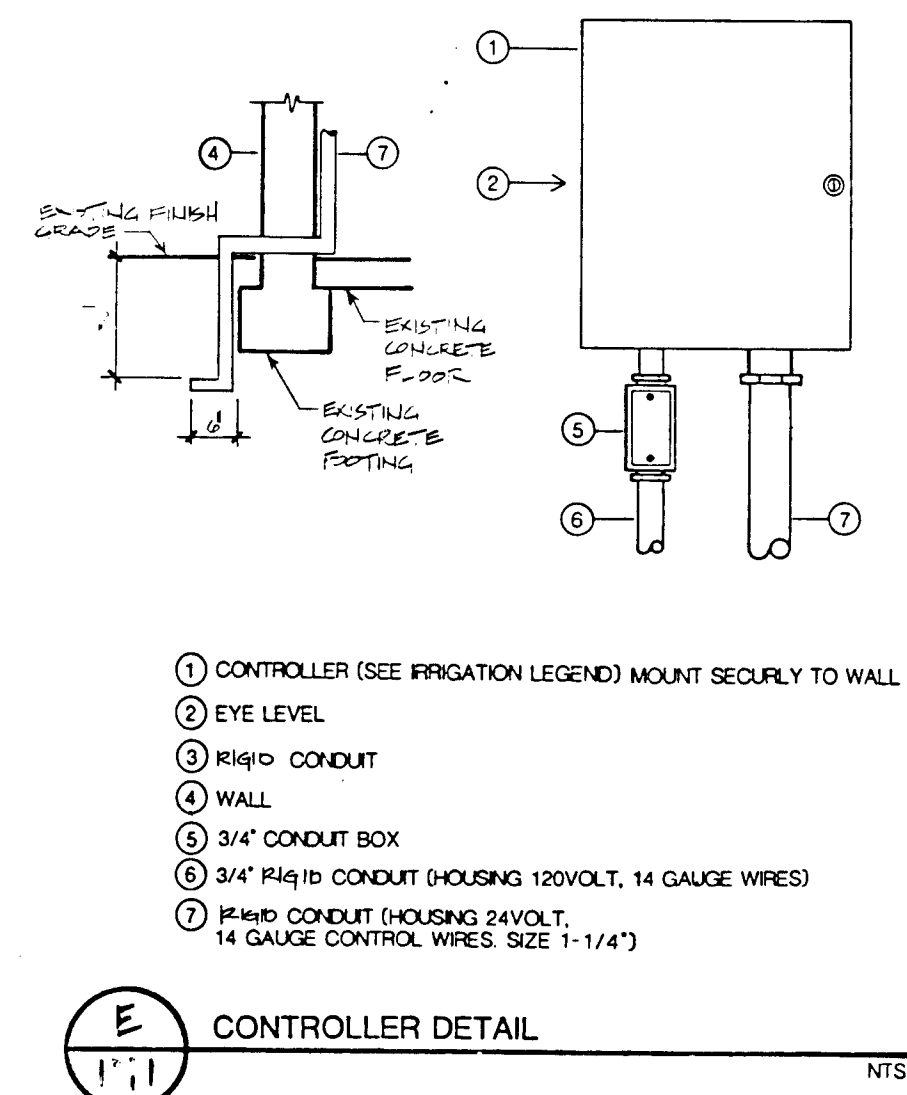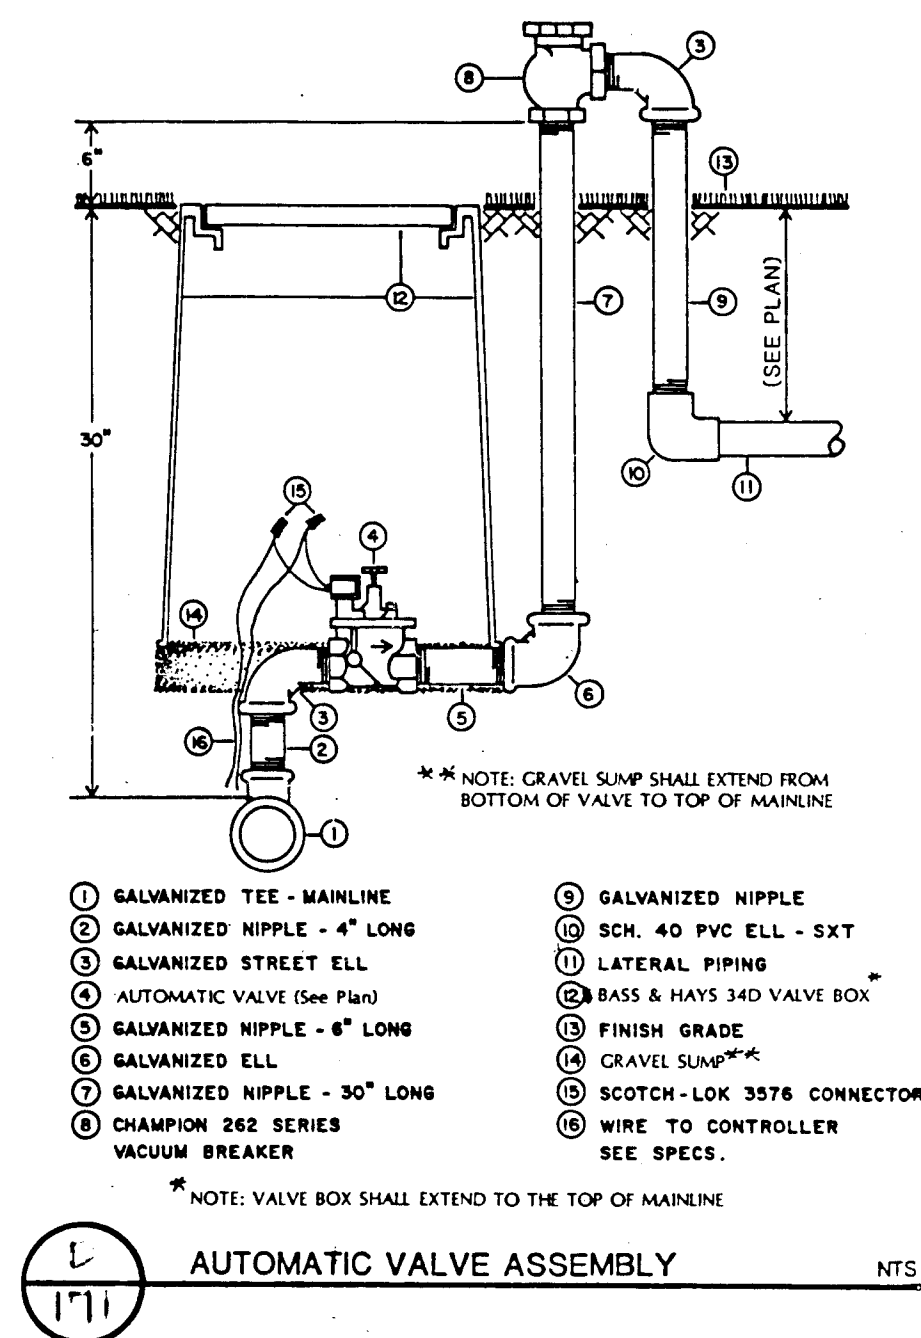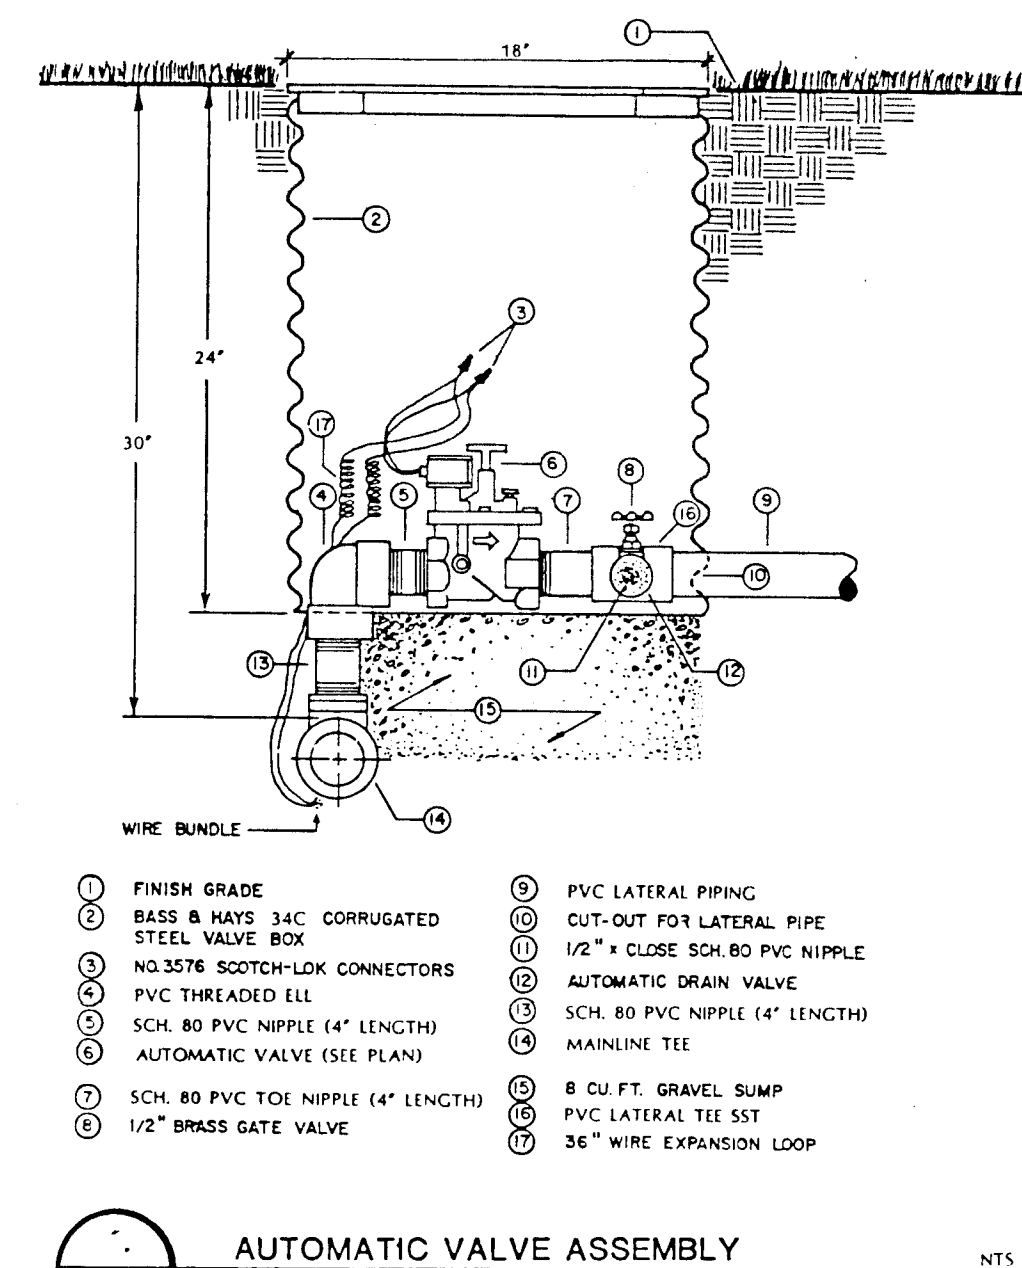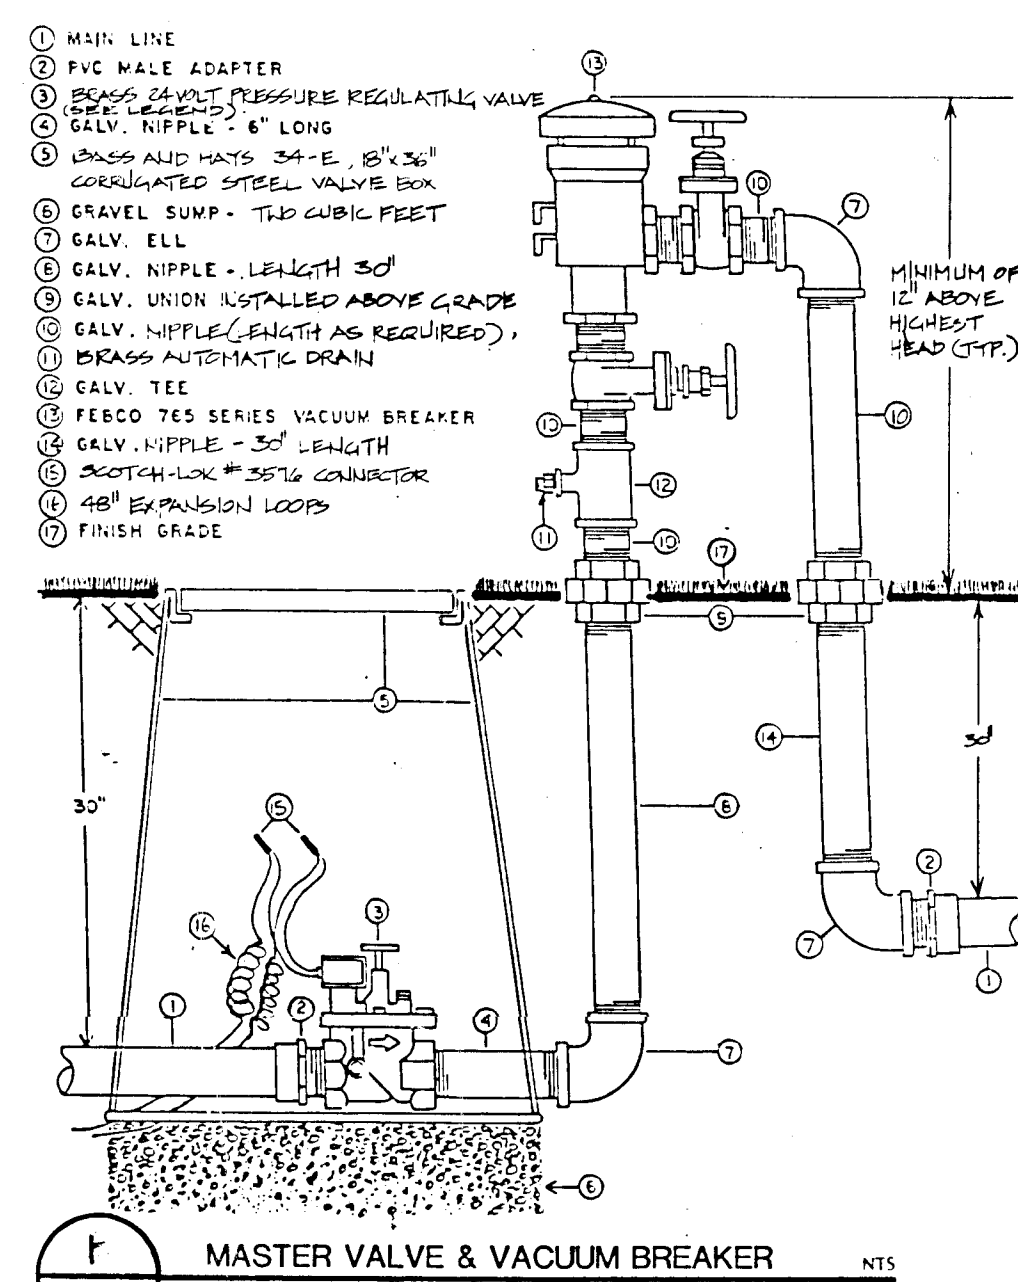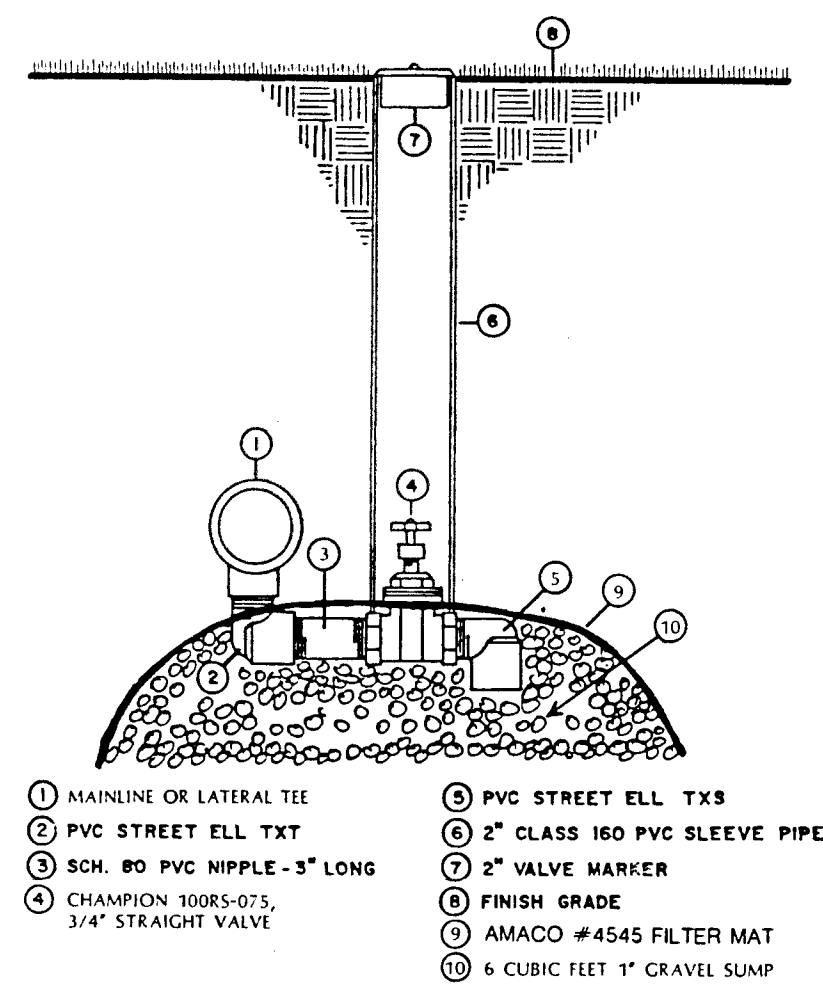


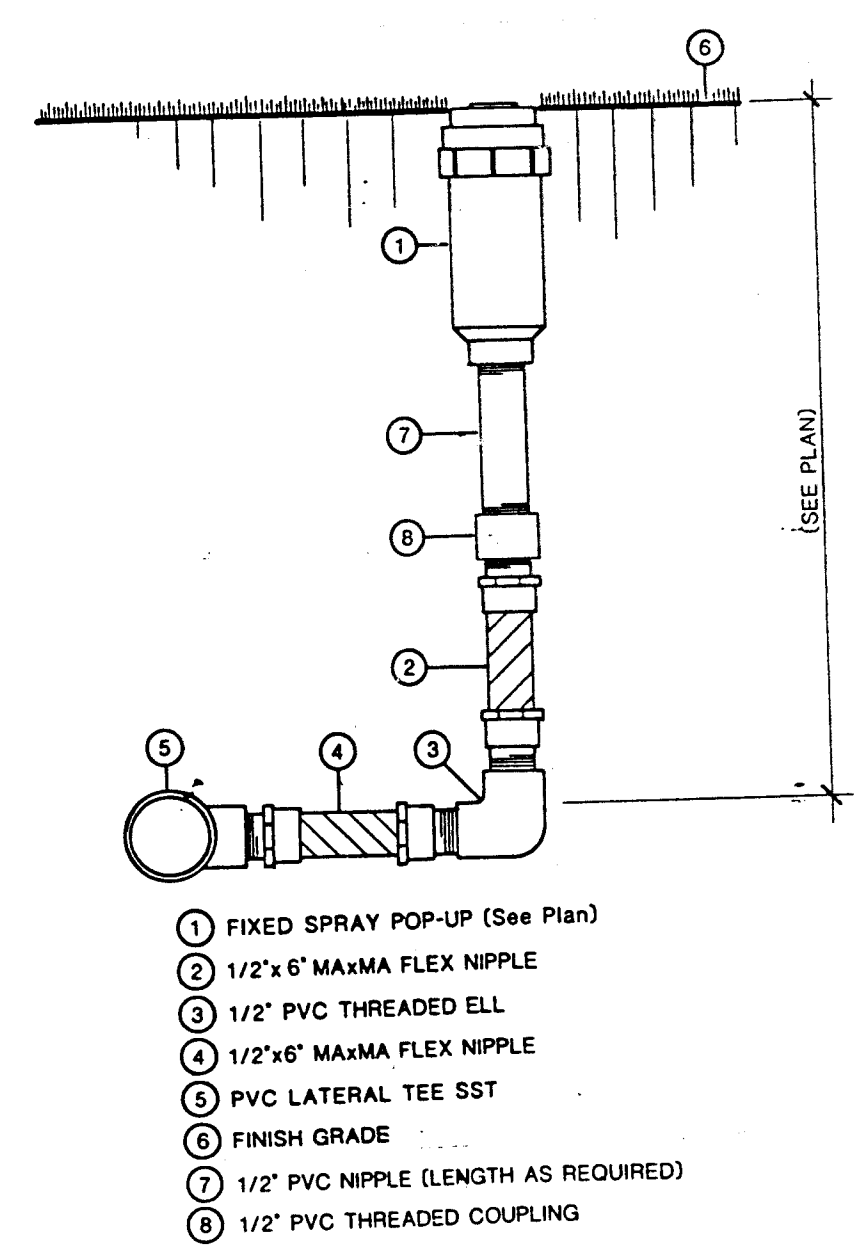


A
172
FIXED SPRAY POP-UP
SPRINKLER ASSEMBLY

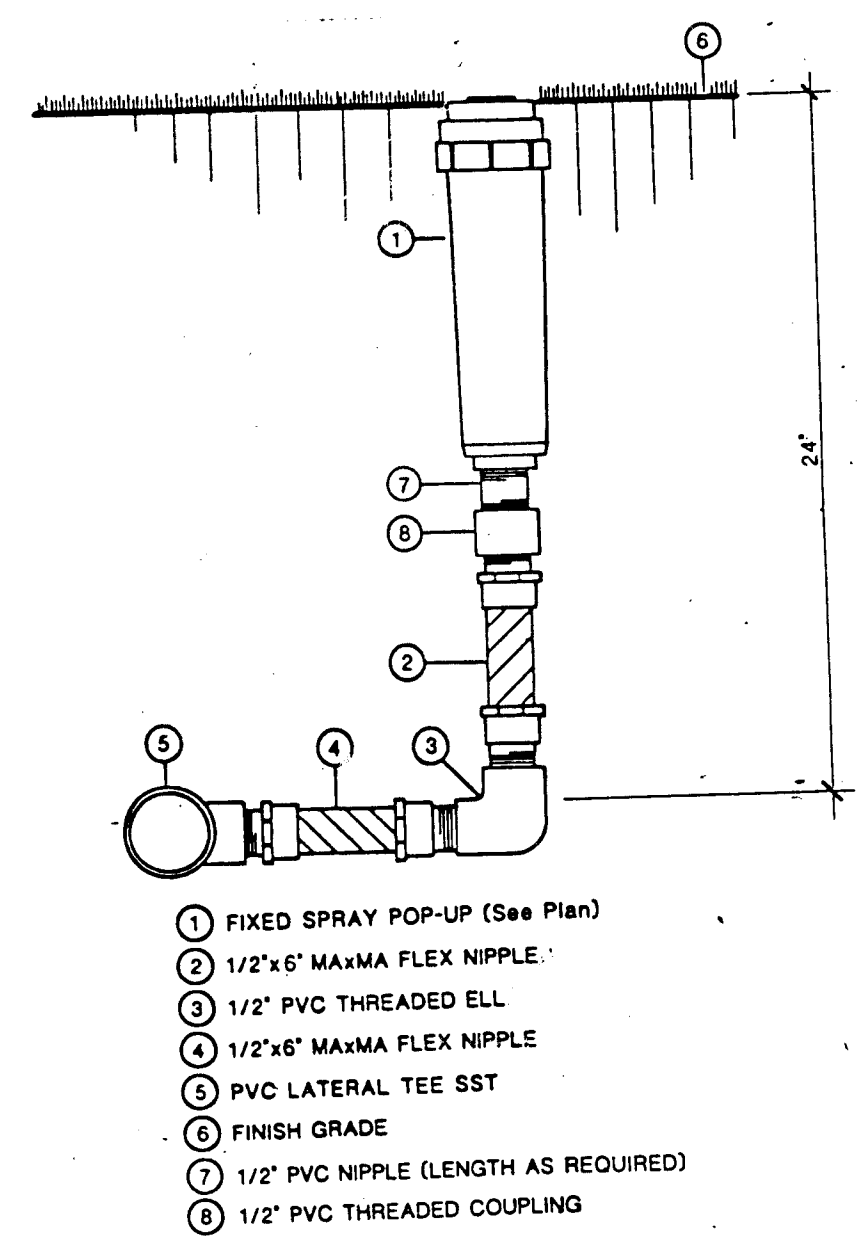


B
172
FIXED SPRAY POP-UP
SPRINKLER ASSEMBLY

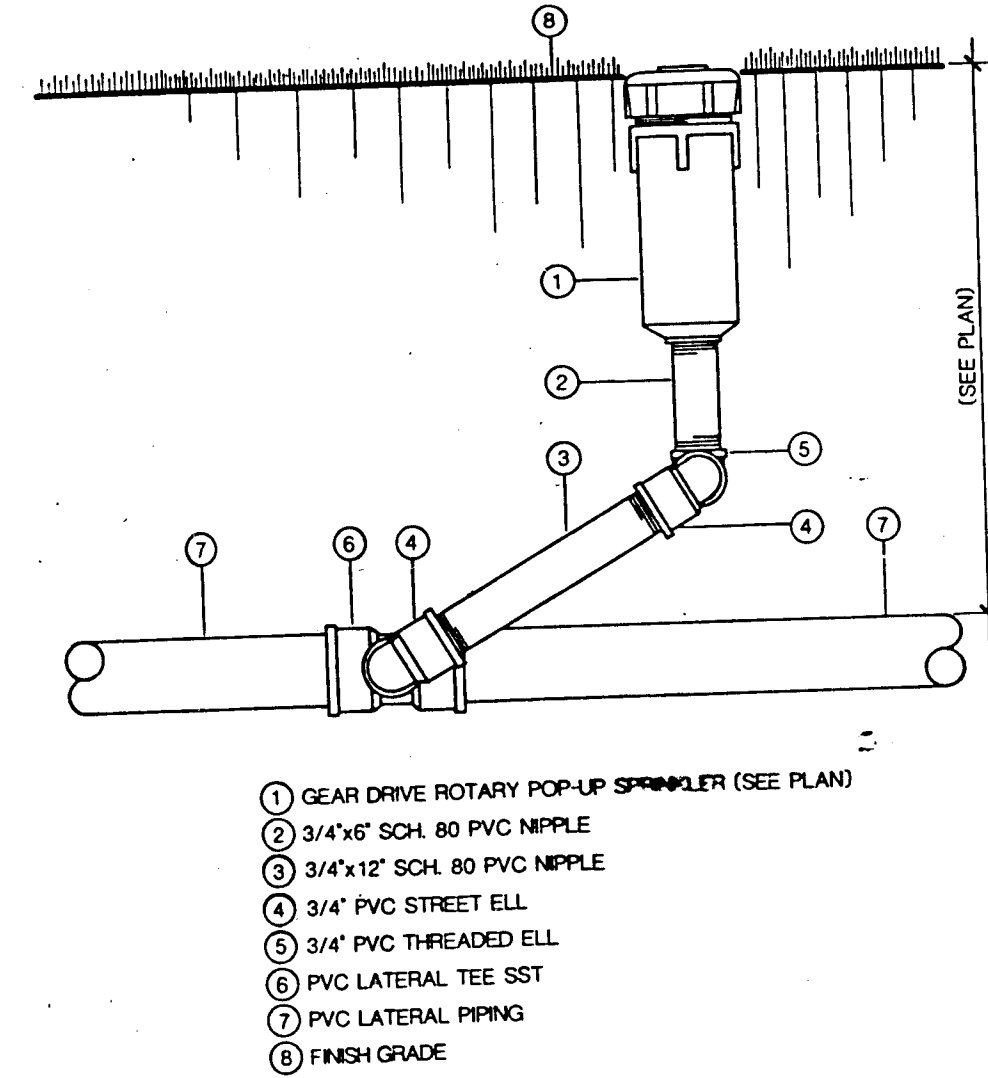


C
172
GEAR DRIVE ROTARY POP-UP SPRINKLER
ON TRIPLE SWING JOINT

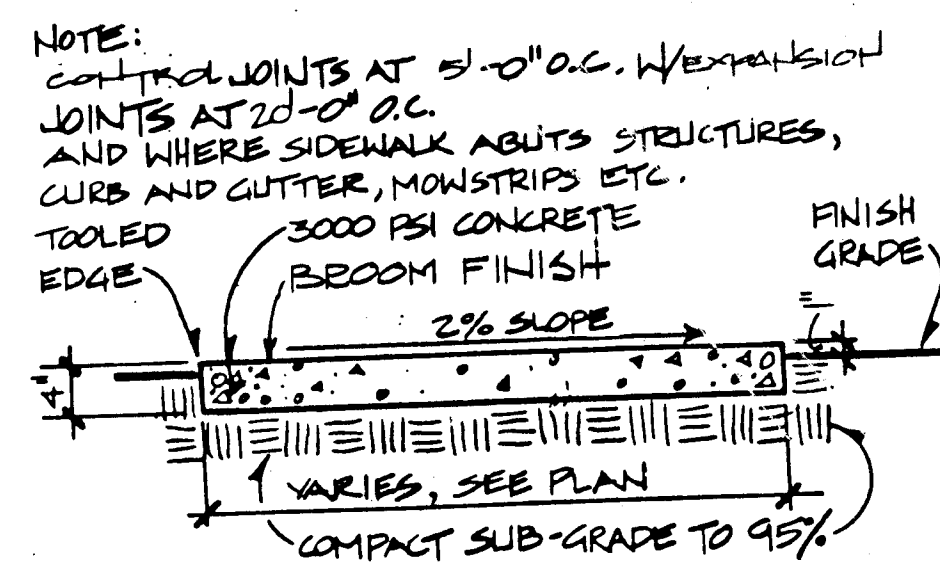

D
172
CONCRETE WALK

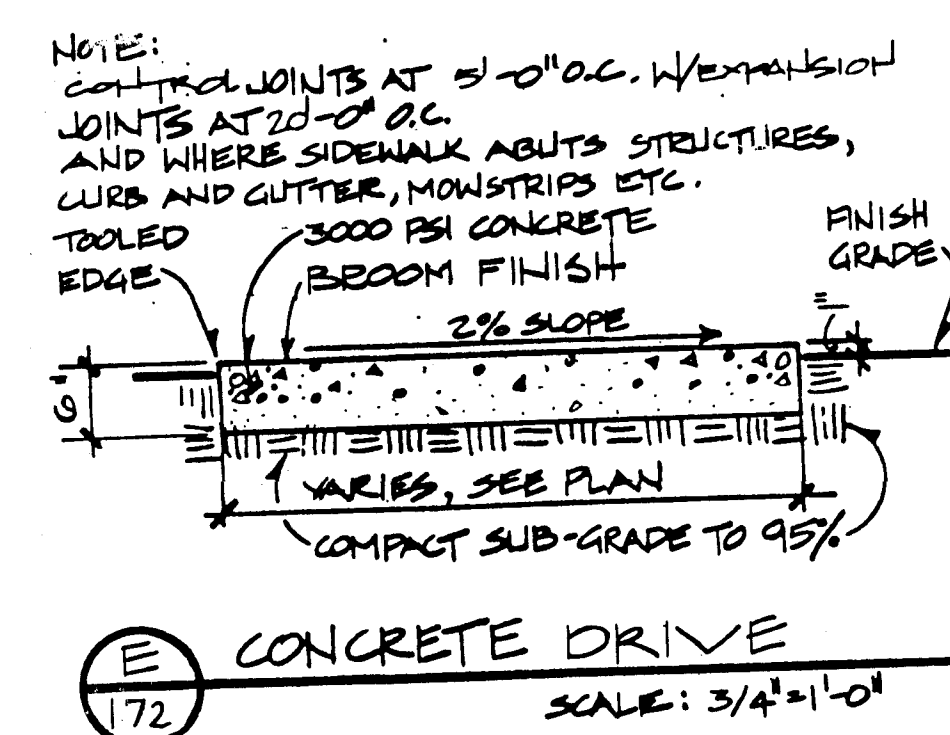

E
172
CONCRETE DRIVE

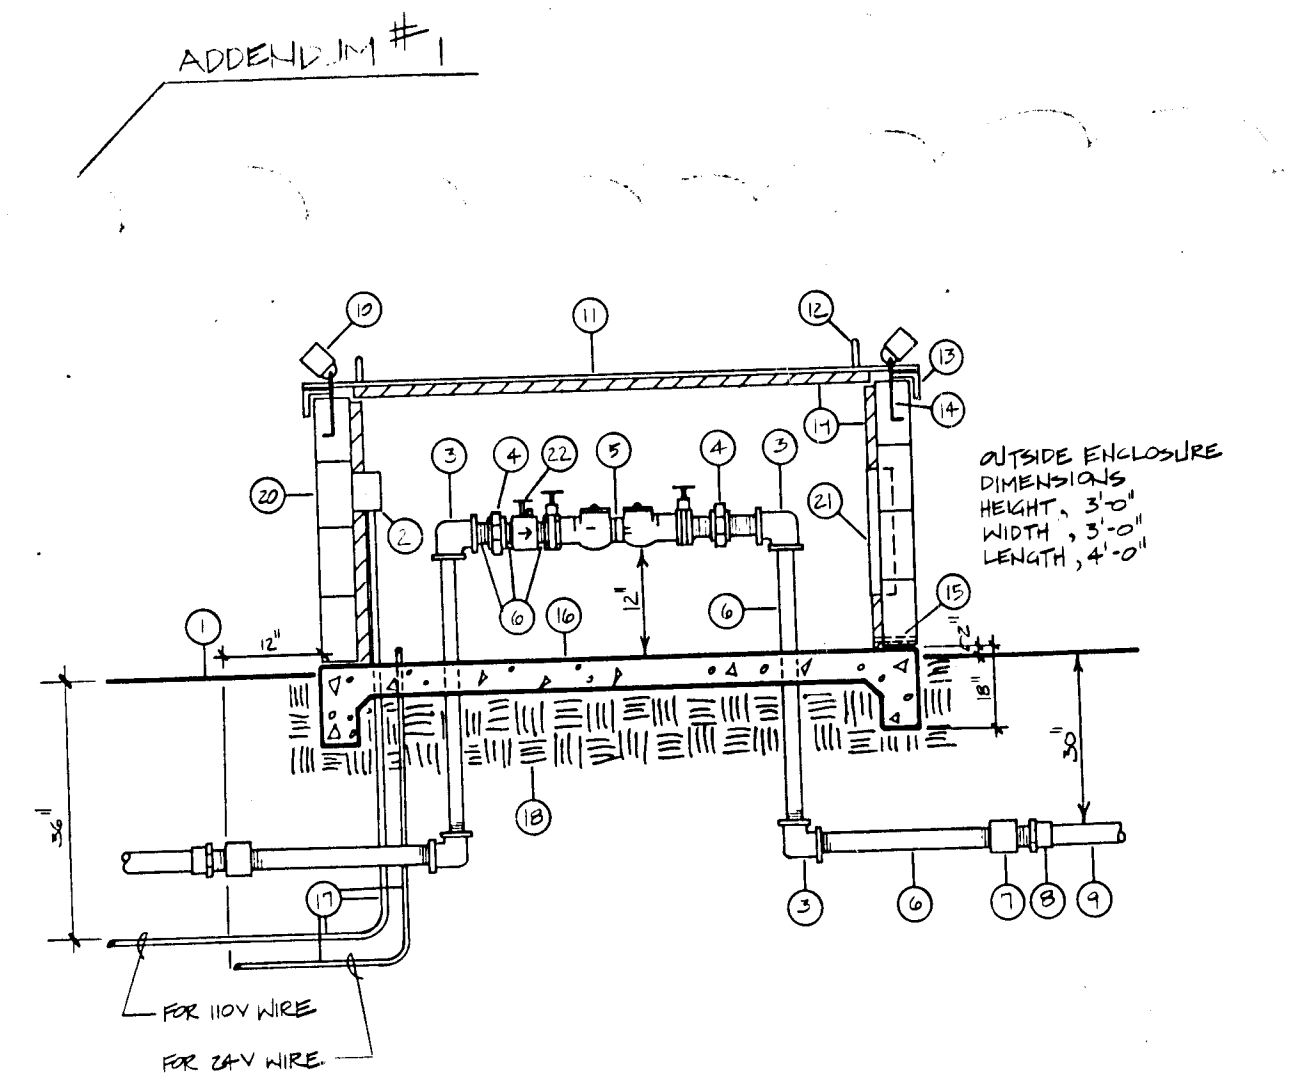


F
172
DOUBLE CHECK BACKFLOW PREVENTOR ASSEMBLY
WITH MASTER VALVE

1. FINISH GRADE
2. VALVE BOX, WEATHER PROOF
3. GALVANIZED 80 ELBOW
4. GALVANIZED UNION
5. FRASCO ROBERT DOUBLE CHECK BACKFLOW PREVENTOR
6. GALVANIZED FITTING, LENGTH AS REQUIRED
7. GALVANIZED COUPLING
8. SCH. 80 PVC MALE ADAPTER
9. PVC MAIN LINE
10. GEAR DRIVE ROTARY
11. 3/4" GALVANIZED STEEL PLATE W/ 1/2" HOLES FOR 1/2" RODS
12. 1/2" GALVANIZED STEEL PLATE W/ 1/2" HOLES FOR 1/2" RODS
13. 1/2" GALVANIZED STEEL PLATE W/ 1/2" HOLES FOR 1/2" RODS
14. 1/2" GALVANIZED STEEL PLATE W/ 1/2" HOLES FOR 1/2" RODS
15. 1/2" GALVANIZED STEEL PLATE W/ 1/2" HOLES FOR 1/2" RODS
16. 1/2" GALVANIZED STEEL PLATE W/ 1/2" HOLES FOR 1/2" RODS
17. 1/2" GALVANIZED STEEL PLATE W/ 1/2" HOLES FOR 1/2" RODS
18. 1/2" GALVANIZED STEEL PLATE W/ 1/2" HOLES FOR 1/2" RODS
19. 1/2" GALVANIZED STEEL PLATE W/ 1/2" HOLES FOR 1/2" RODS
20. 1/2" GALVANIZED STEEL PLATE W/ 1/2" HOLES FOR 1/2" RODS


1. FINISH GRADE
2. VALVE BOX, WEATHER PROOF
3. GALVANIZED 80 ELBOW
4. GALVANIZED UNION
5. FRASCO ROBERT DOUBLE CHECK BACKFLOW PREVENTOR
6. GALVANIZED FITTING, LENGTH AS REQUIRED
7. GALVANIZED COUPLING
8. SCH. 80 PVC MALE ADAPTER
9. PVC MAIN LINE
10. GEAR DRIVE ROTARY
11. 3/4" GALVANIZED STEEL PLATE W/ 1/2" HOLES FOR 1/2" RODS
12. 1/2" GALVANIZED STEEL PLATE W/ 1/2" HOLES FOR 1/2" RODS
13. 1/2" GALVANIZED STEEL PLATE W/ 1/2" HOLES FOR 1/2" RODS
14. 1/2" GALVANIZED STEEL PLATE W/ 1/2" HOLES FOR 1/2" RODS
15. 1/2" GALVANIZED STEEL PLATE W/ 1/2" HOLES FOR 1/2" RODS
16. 1/2" GALVANIZED STEEL PLATE W/ 1/2" HOLES FOR 1/2" RODS
17. 1/2" GALVANIZED STEEL PLATE W/ 1/2" HOLES FOR 1/2" RODS
18. 1/2" GALVANIZED STEEL PLATE W/ 1/2" HOLES FOR 1/2" RODS
19. 1/2" GALVANIZED STEEL PLATE W/ 1/2" HOLES FOR 1/2" RODS
20. 1/2" GALVANIZED STEEL PLATE W/ 1/2" HOLES FOR 1/2" RODS

1. FINISH GRADE
2. VALVE BOX, WEATHER PROOF
3. GALVANIZED 80 ELBOW
4. GALVANIZED UNION
5. FRASCO ROBERT DOUBLE CHECK BACKFLOW PREVENTOR
6. GALVANIZED FITTING, LENGTH AS REQUIRED
7. GALVANIZED COUPLING
8. SCH. 80 PVC MALE ADAPTER
9. PVC MAIN LINE
10. GEAR DRIVE ROTARY
11. 3/4" GALVANIZED STEEL PLATE W/ 1/2" HOLES FOR 1/2" RODS
12. 1/2" GALVANIZED STEEL PLATE W/ 1/2" HOLES FOR 1/2" RODS
13. 1/2" GALVANIZED STEEL PLATE W/ 1/2" HOLES FOR 1/2" RODS
14. 1/2" GALVANIZED STEEL PLATE W/ 1/2" HOLES FOR 1/2" RODS
15. 1/2" GALVANIZED STEEL PLATE W/ 1/2" HOLES FOR 1/2" RODS
16. 1/2" GALVANIZED STEEL PLATE W/ 1/2" HOLES FOR 1/2" RODS
17. 1/2" GALVANIZED STEEL PLATE W/ 1/2" HOLES FOR 1/2" RODS
18. 1/2" GALVANIZED STEEL PLATE W/ 1/2" HOLES FOR 1/2" RODS
19. 1/2" GALVANIZED STEEL PLATE W/ 1/2" HOLES FOR 1/2" RODS
20. 1/2" GALVANIZED STEEL PLATE W/ 1/2" HOLES FOR 1/2" RODS

26 309714486

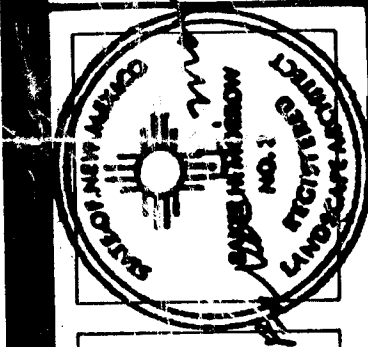

MORROW & COMPANY
LANDSCAPE ARCHITECTS
210 La Veta Drive NE
Albuquerque, New Mexico 87108
505-268-2266

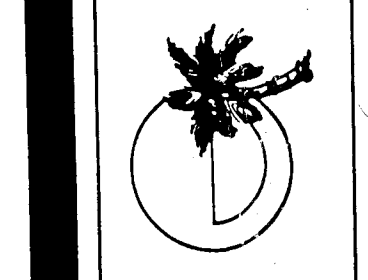


NOVEMBER
1986

AS BUILT

DETAILS


LANDSCAPING IMPROVEMENTS FOR
WATER SYSTEM FACILITY SITES
WATER SYSTEMS DIVISION
CITY OF ALBUQUERQUE
ALBUQUERQUE, NEW MEXICO

SHEET
172
OF
172

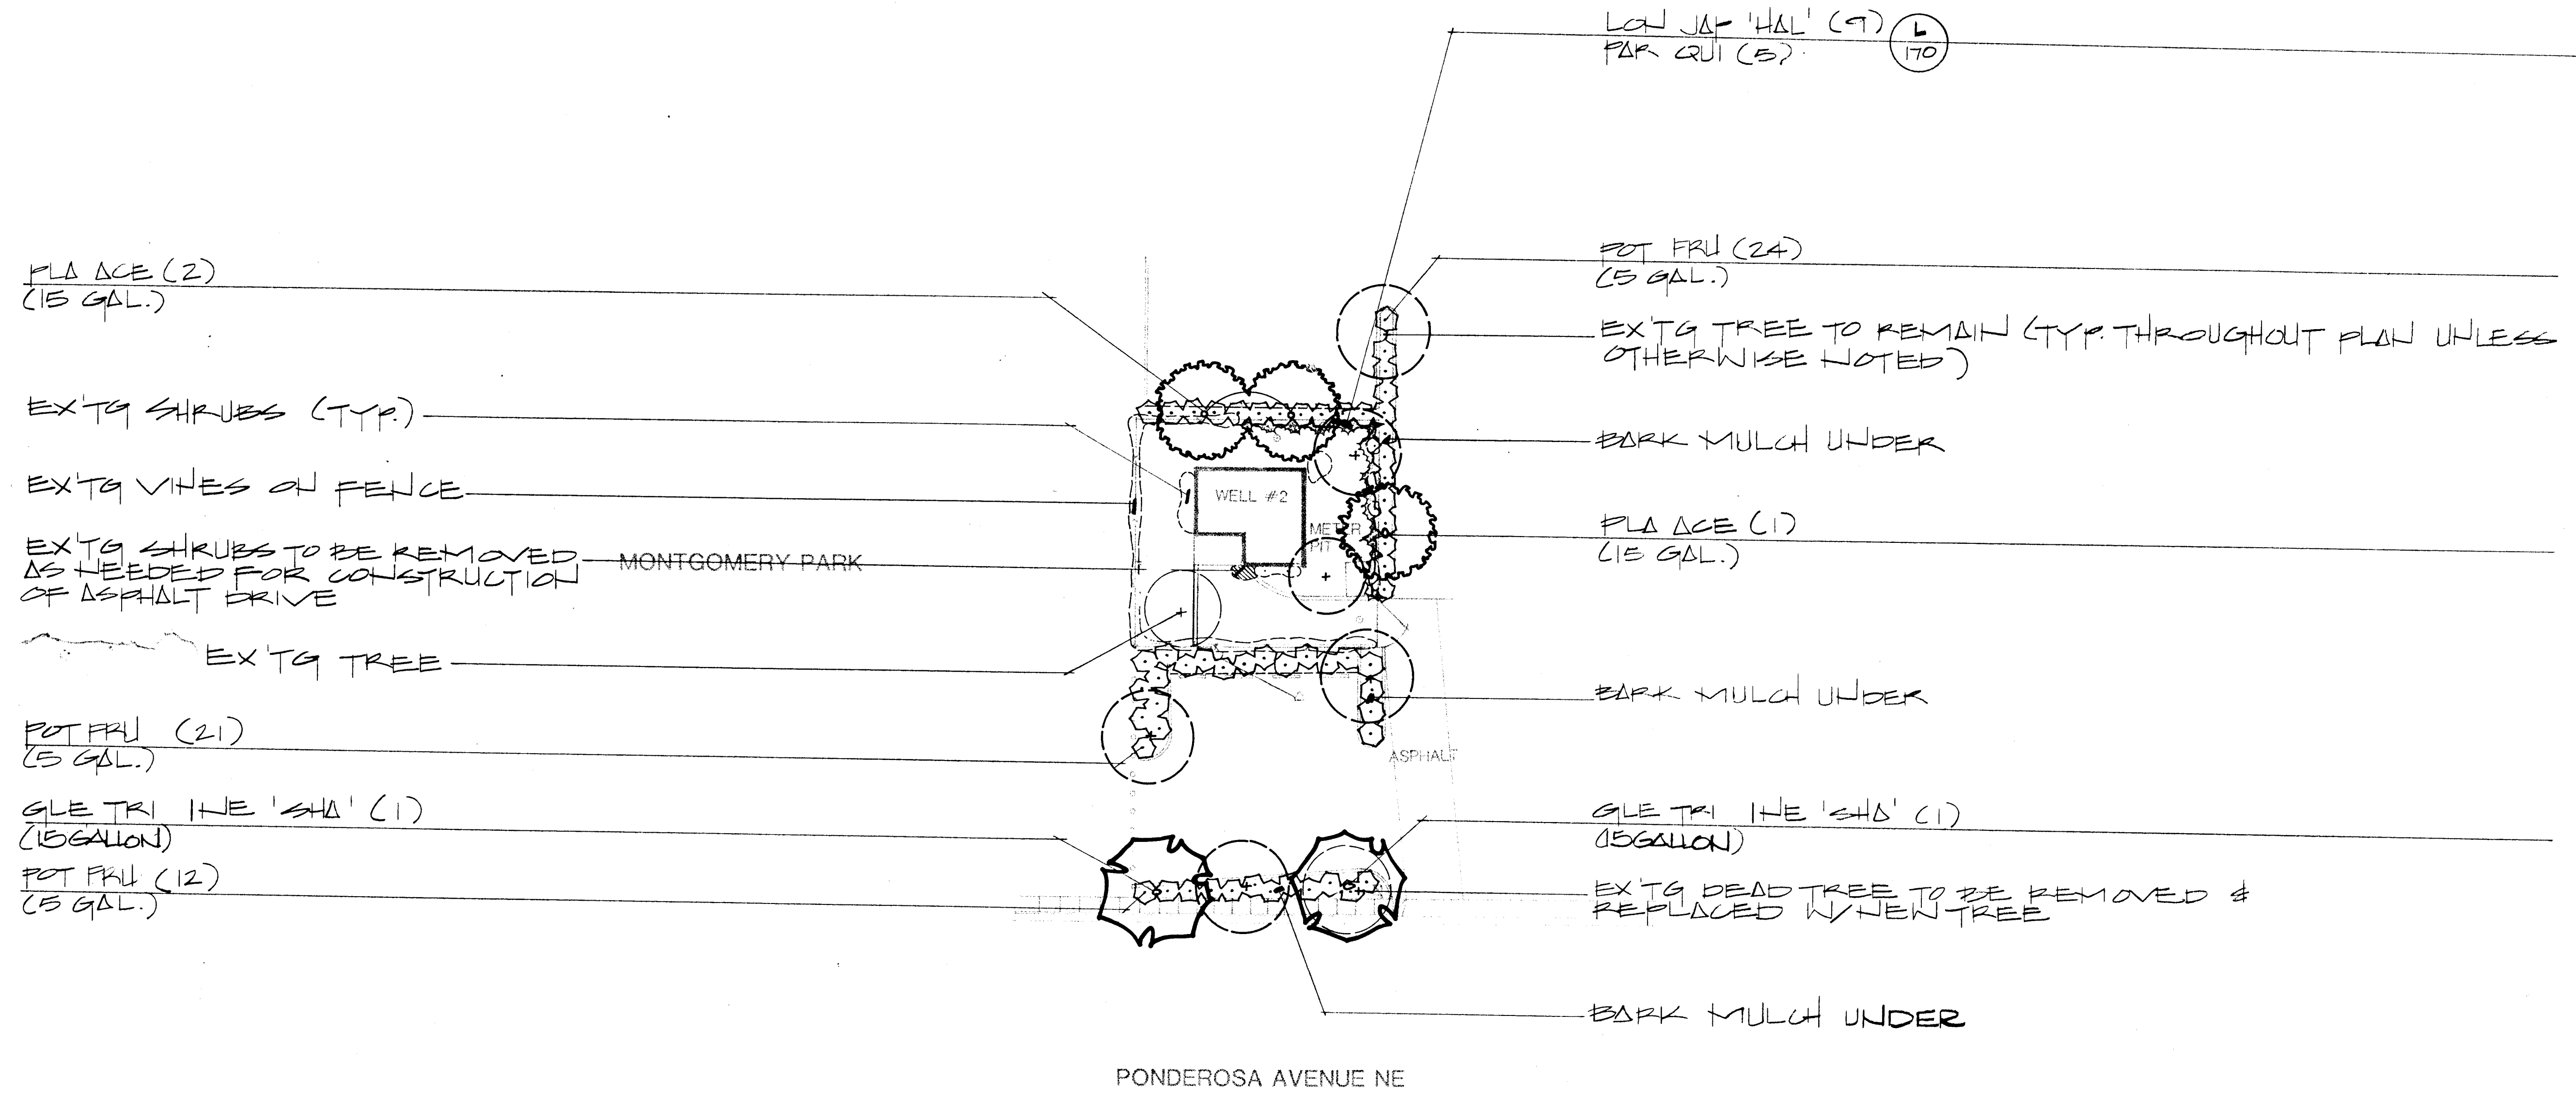

SCALE 1"=20'-0"
 0 10 20 40

26 309712886

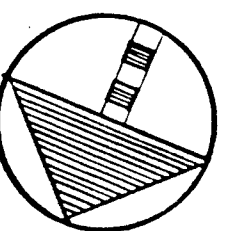



MORROW & COMPANY
 LANDSCAPE ARCHITECTS
 210 La Veta Drive NE
 Albuquerque, New Mexico 87108
 505-268-2266

NOVEMBER 1986

AS BUILT

VOL-ANDIA WELL #2
5212 PONDEROSA AVENUE NE
PLANTING PLAN

LANDSCAPING IMPROVEMENTS FOR
WATER SYSTEM FACILITY SITES
WATER SYSTEMS DIVISION
CITY OF ALBUQUERQUE
ALBUQUERQUE, NEW MEXICO

SHEET

149
OF
172