


CONSTRUCTION PLANS FOR ST. JOSEPH HOSPITAL COMPLEX ALBUQUERQUE, NEW MEXICO

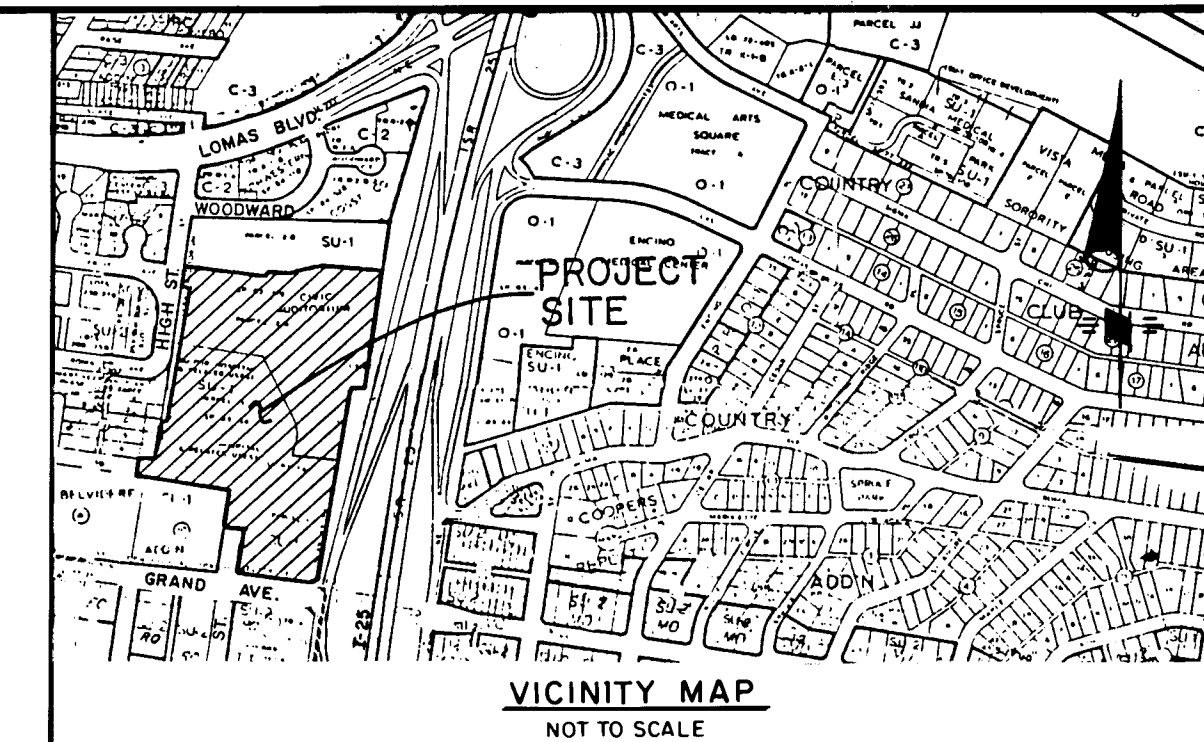

GENERAL NOTES

NOTICE TO CONTRACTORS

- ALL WORK DETAILED ON THESE PLANS TO BE PERFORMED UNDER CONTRACT SHALL, EXCEPT AS OTHERWISE STATED OR PROVIDED FOR HEREON, BE CONSTRUCTED IN ACCORDANCE WITH CITY OF ALBUQUERQUE INTERIM STANDARD SPECIFICATIONS PUBLIC WORKS CONSTRUCTION, 1985 EDITION.
- TWO WORKING DAYS PRIOR TO ANY EXCAVATION, CONTRACTOR MUST CONTACT LINE LOCATING SERVICE, 765-1234, FOR LOCATION OF EXISTING UTILITIES.
- PRIOR TO CONSTRUCTION, THE CONTRACTOR SHALL EXCAVATE AND VERIFY THE HORIZONTAL AND VERTICAL LOCATIONS OF ALL OBSTRUCTIONS. SHOULD A CONFLICT EXIST, THE CONTRACTOR SHALL NOTIFY THE ENGINEER OR SURVEYOR SO THAT THE CONFLICT CAN BE RESOLVED WITH A MINIMUM AMOUNT OF DELAY.



THE FOLLOWING NOTES ALSO APPLY WHEN CHECKED

- ☒ ALL UTILITIES AND UTILITY SERVICE LINES SHALL BE INSTALLED PRIOR TO PAVING.
- ☒ BACKFILL COMPACTION SHALL BE ACCORDING TO SPECIFIED STREET USE.
- ☒ TACK COAT REQUIREMENTS SHALL BE DETERMINED BY THE CITY ENGINEER.
- ☐ SIDEWALKS AND WHEELCHAIR RAMPS WITHIN THE CURB RETURNS SHALL BE CONSTRUCTED WHEREVER A NEW CURB RETURN IS CONSTRUCTED.
- ☒ IF CURB IS DEPRESSIONED FOR A DRIVEPAD, THE DRIVEPAD SHALL BE CONSTRUCTED PRIOR TO ACCEPTANCE OF CURB AND GUTTER.
- ☒ ALL STORM DRAINAGE FACILITIES SHALL BE COMPLETED PRIOR TO FINAL ACCEPTANCE.
- ☒ THE REQUESTOR OR DEVELOPER SHALL BE RESPONSIBLE FOR REPAIR OR REPLACEMENT OF ALL CURB AND GUTTER OR SIDEWALK DAMAGED AFTER APPROVAL BY THE CITY ENGINEER OF WORK COMPLETED BY THE CONTRACTOR.

SHEET NO.	DESCRIPTION
1	TITLE SHEET
2	SUBDIVISION PLAT
3	DRAINAGE / GRADING PLAN
4	DRAINAGE DETAILS
5	WATER & SANITARY SEWER DISTRIBUTION PLAN
6	STREET PAVING & STORM DRAINAGE OVERALL PLAN
7	HIGH STREET / FRUIT AVENUE / ELM STREET PLAN & PROFILE (WATER & STREET PAVING)
8	ELM STREET PLAN & PROFILE (WATER & STREET PAVING)
9	MARQUETTE AVENUE (VACATED) PLAN & PROFILE (WATER, SANITARY SEWER, STREET PAVING, & STORM DRAIN)
10	COPPER STREET-ELM STREET WATER CONNECTION PLAN & PROFILE

RECORD DRAWINGS



DATE

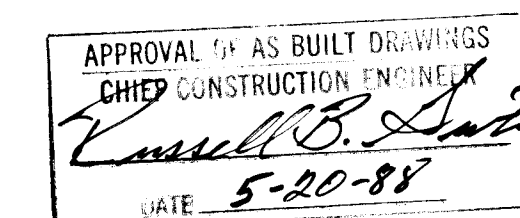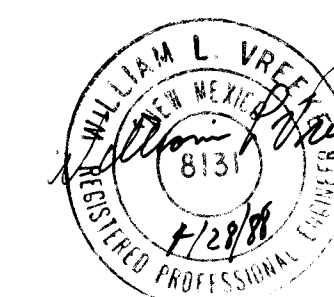


1	2	3	4	5	6	7	8	9	10	11	12
26	31	56	01	88							


REV	SHEETS	CITY ENGINEER	DATE	USER	DEPT.	DATE	USER	DEPT.	DATE


APPROVAL OF REVISIONS

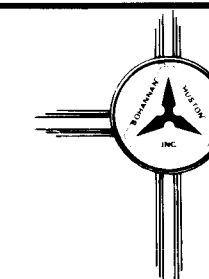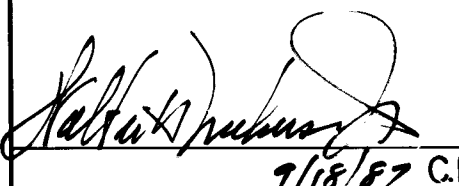	 BOHANNON - HUSTON INC. ALBUQUERQUE - SANTA FE - EL PASO ENGINEERS PLANNERS PHOTOGRAMMETRISTS	APPROVED FOR CONSTRUCTION  7/18/87 C.E.
	PROJECT NUMBER 3156	SHEET 1 OF 10

10

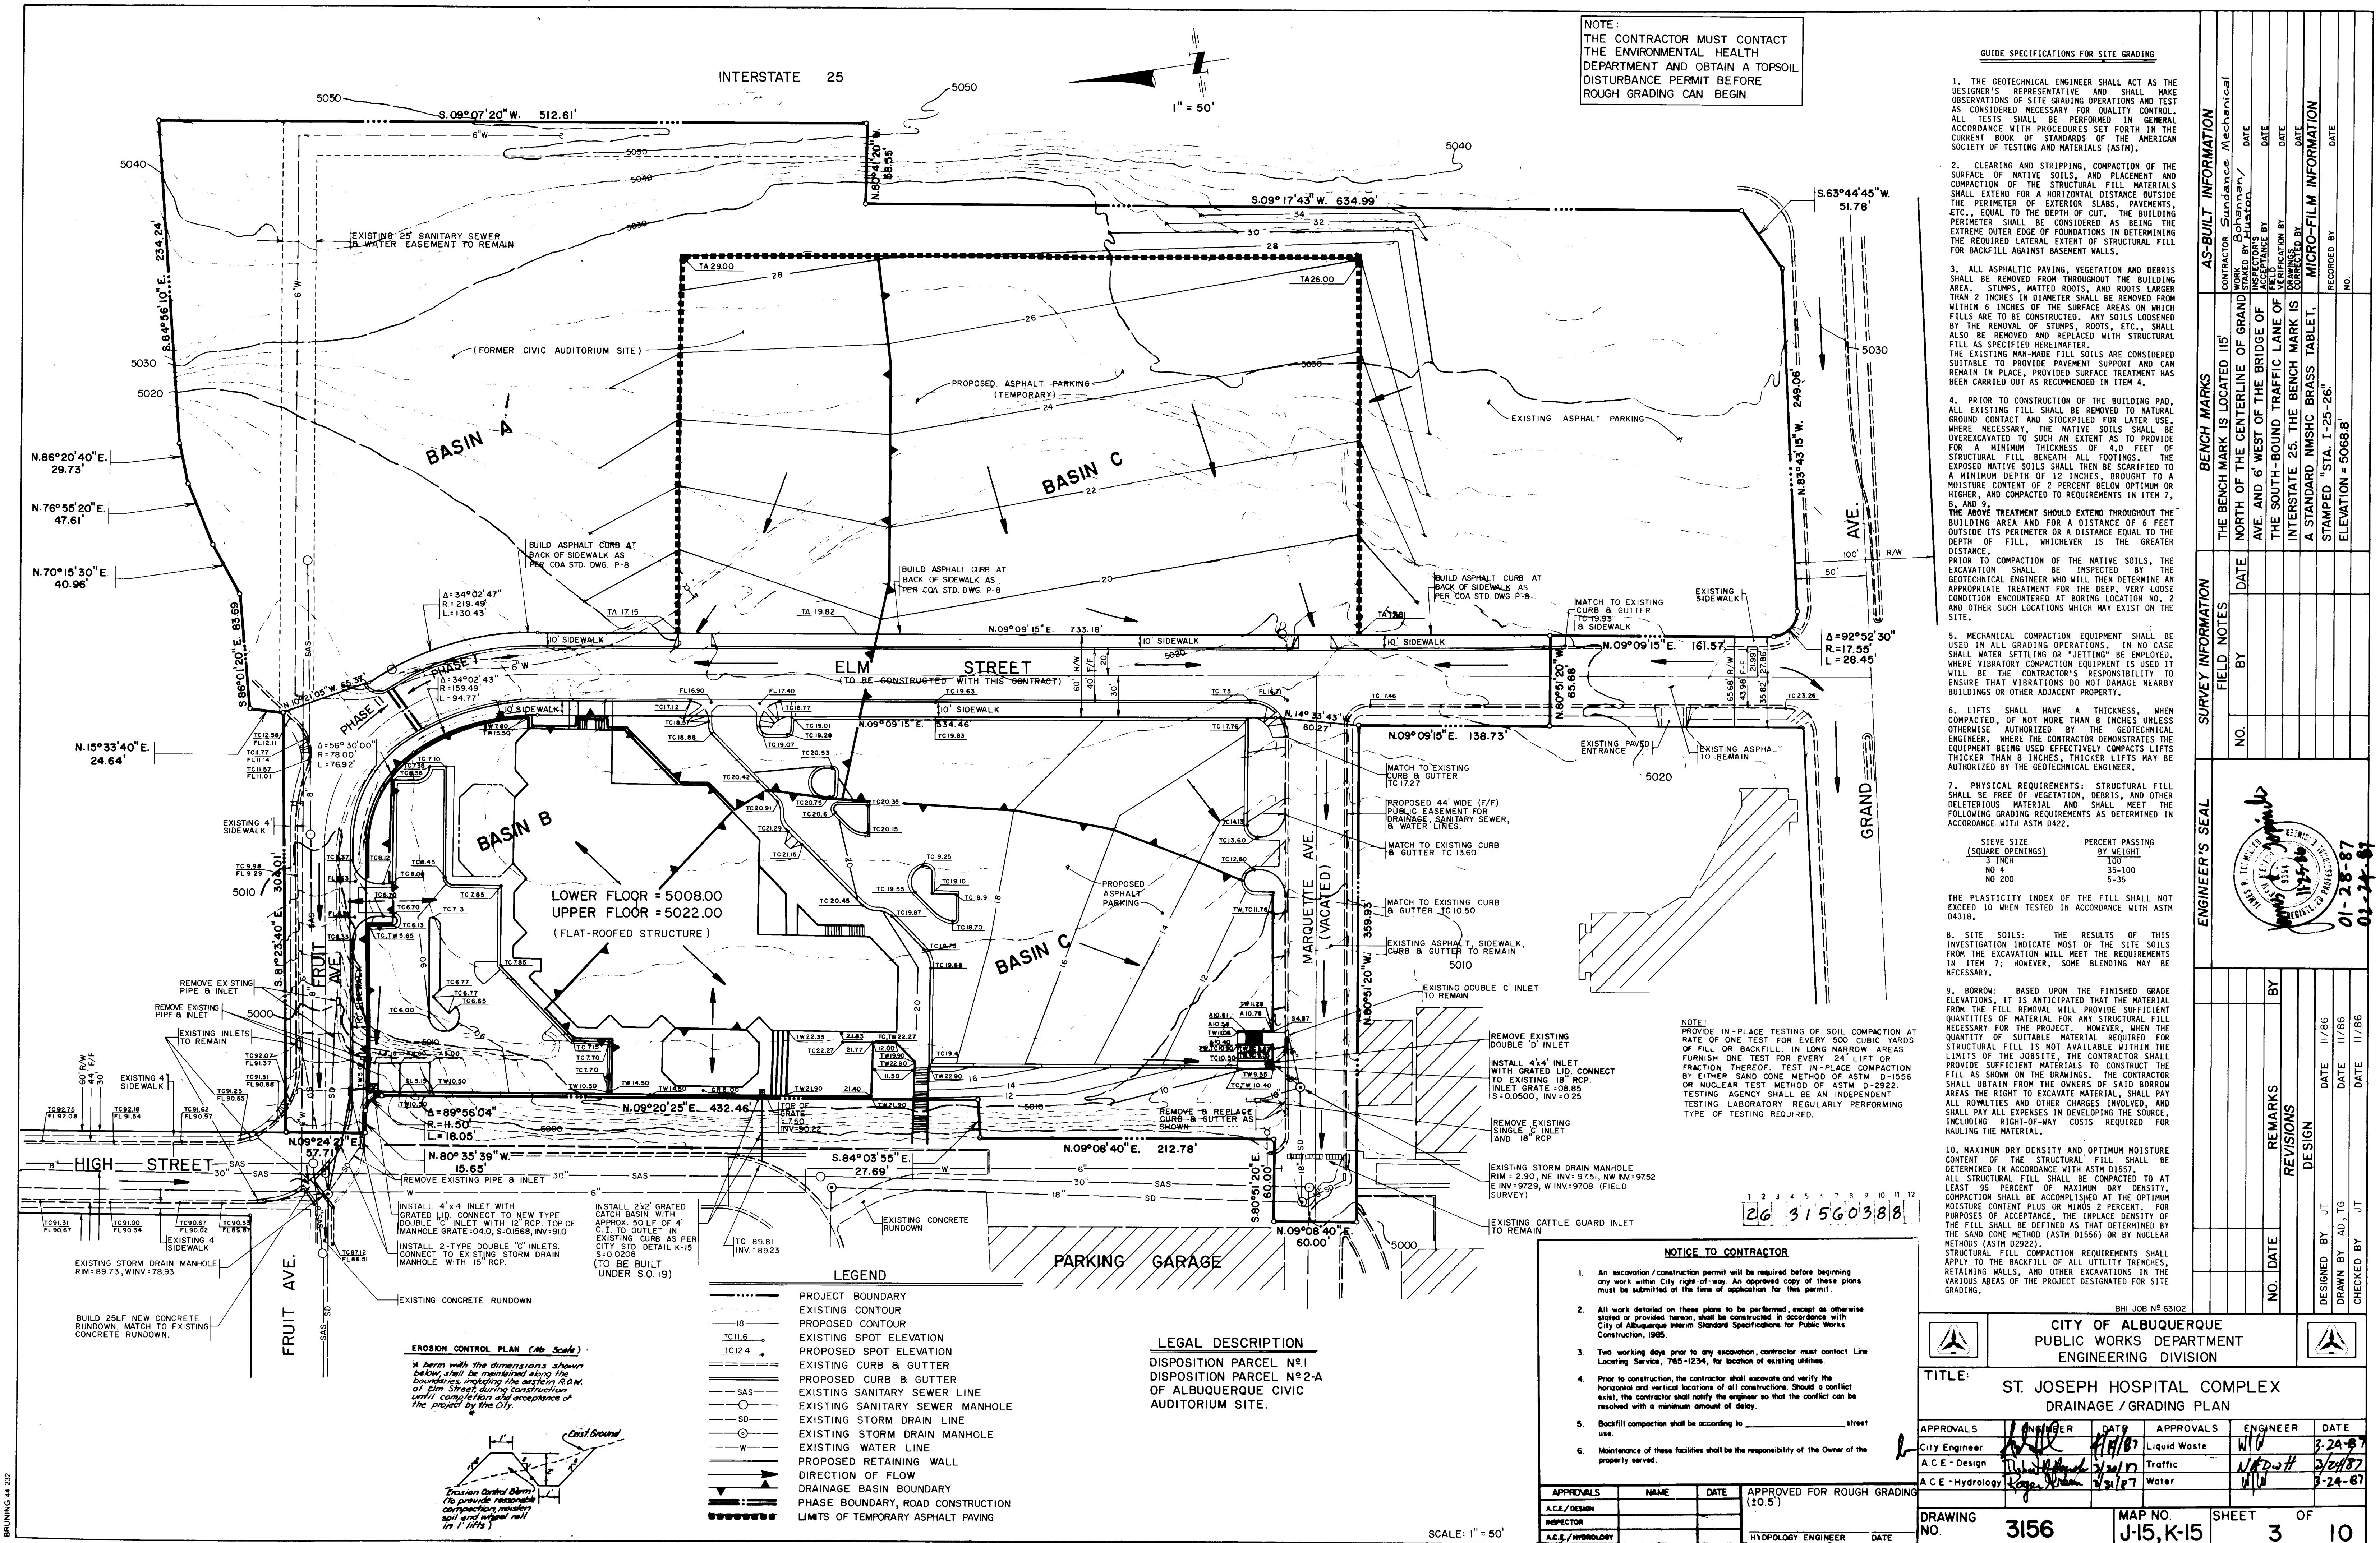


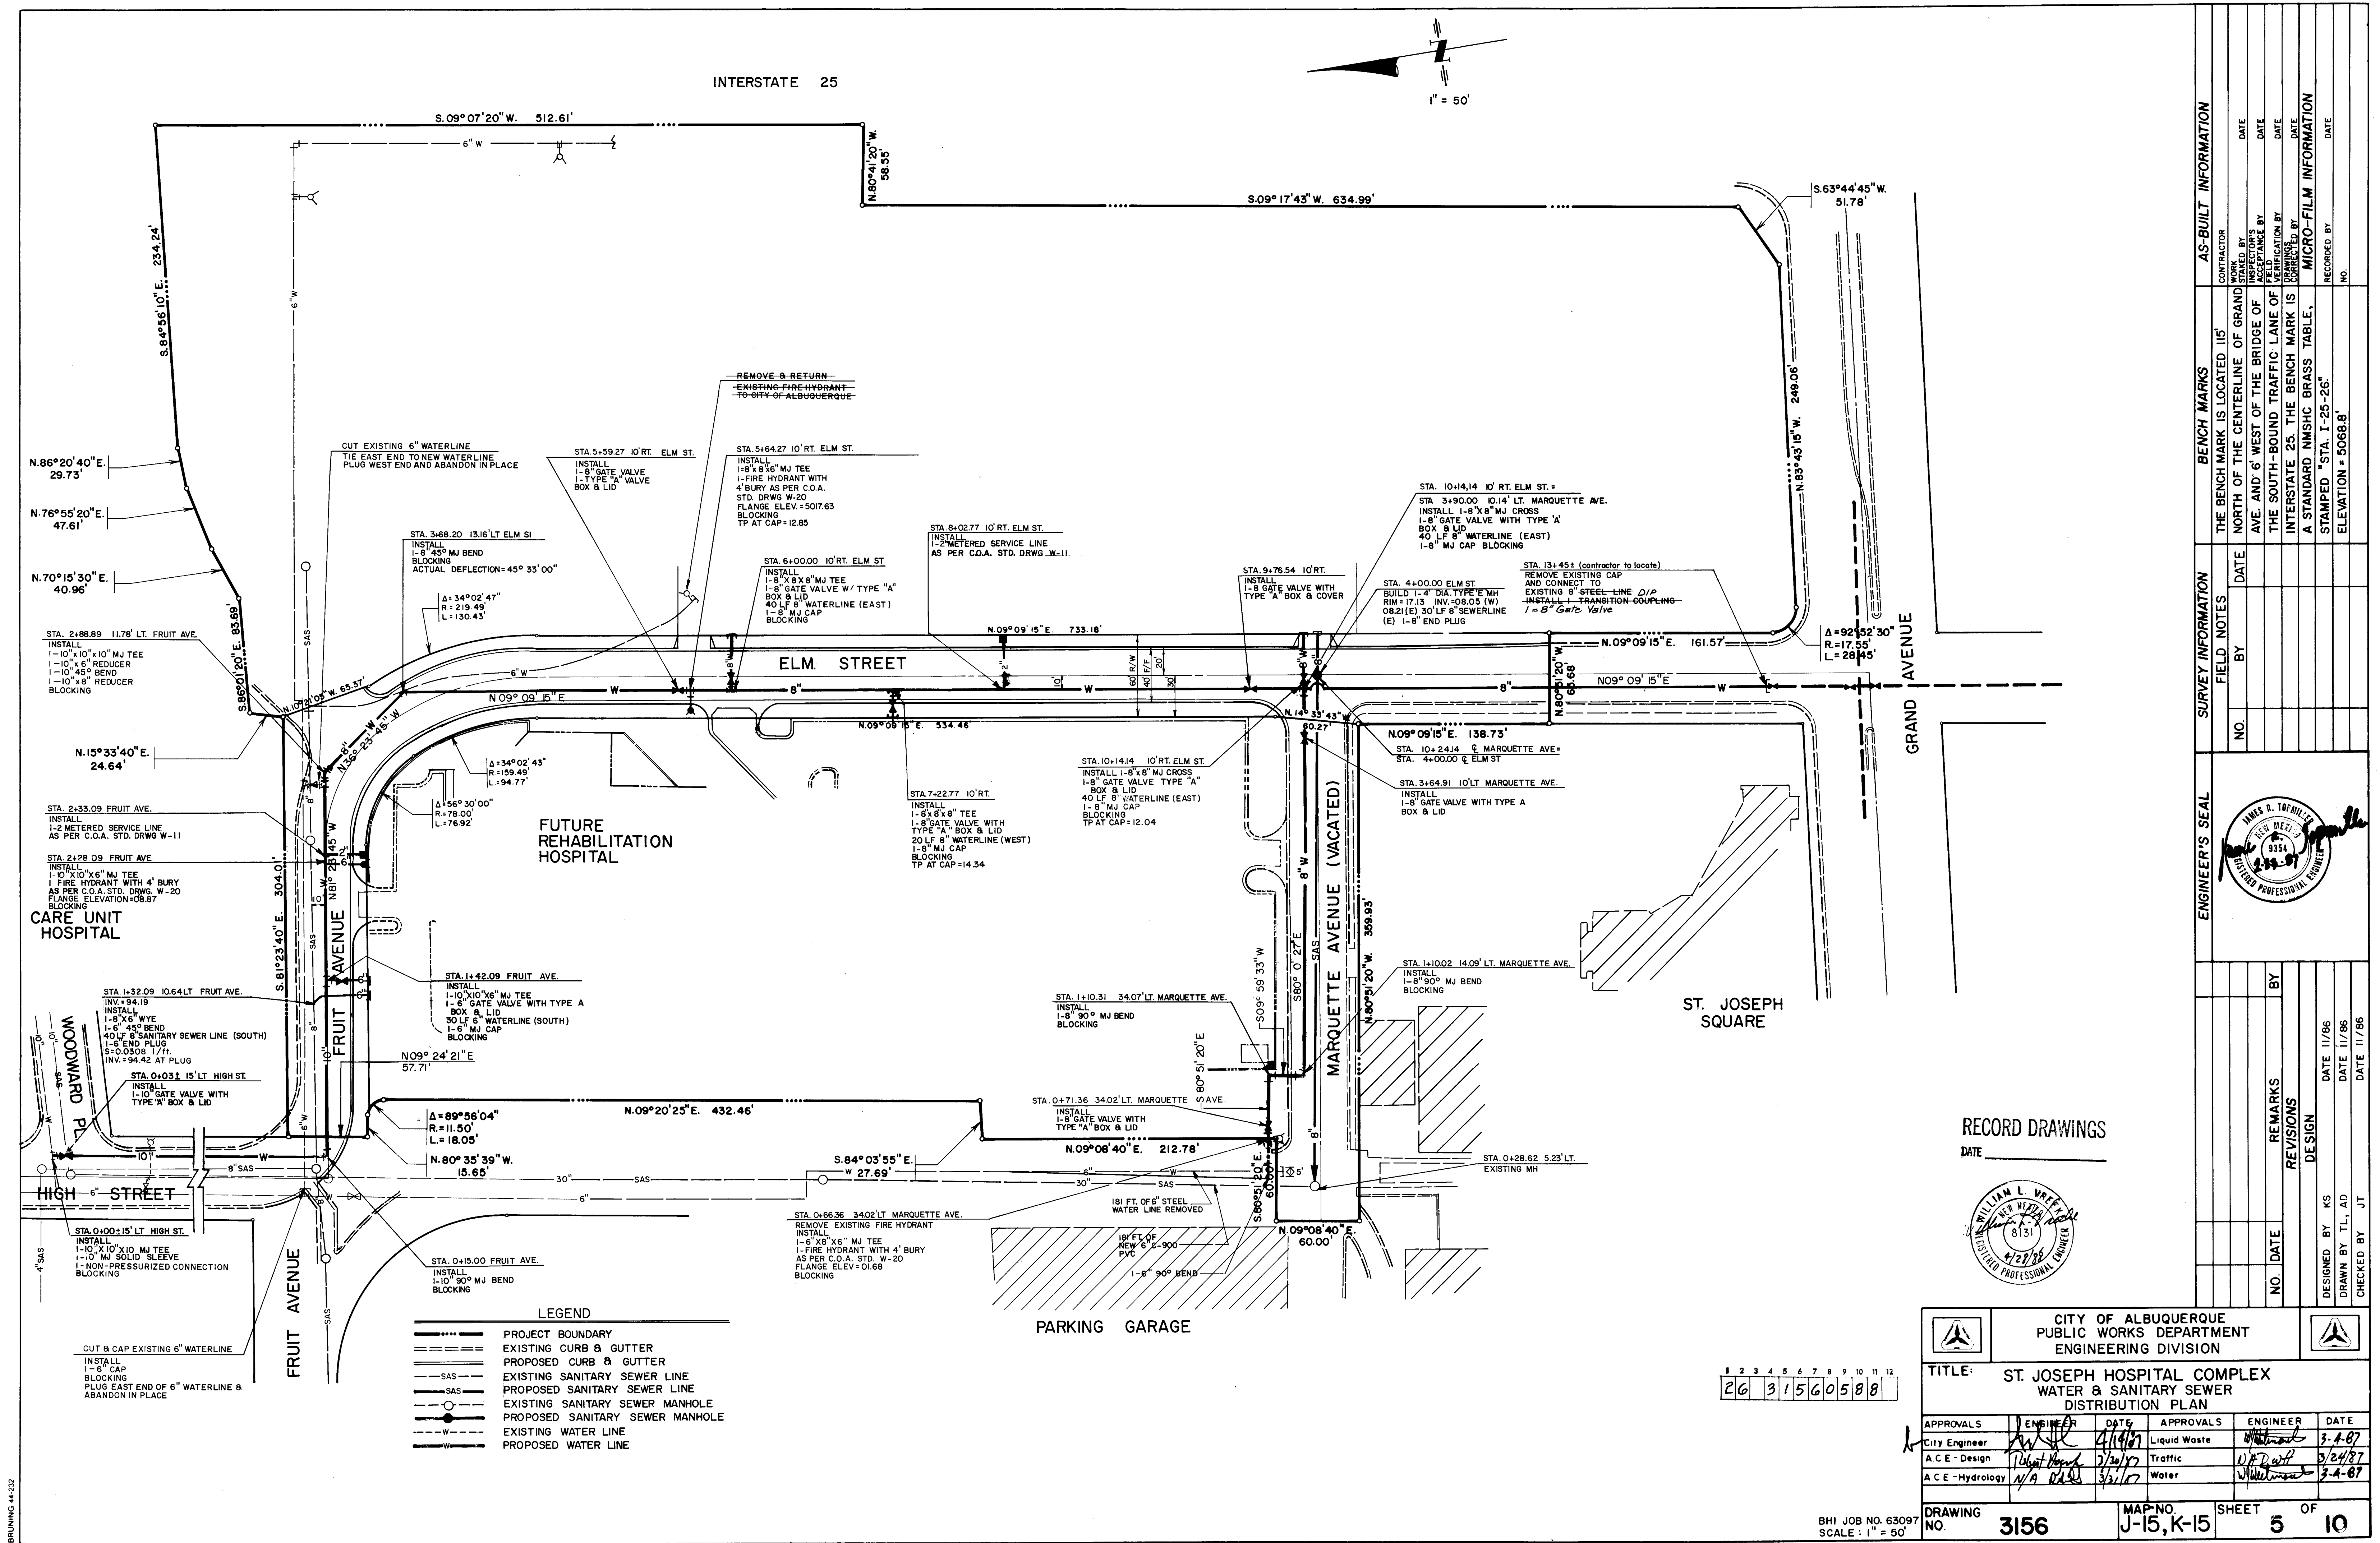


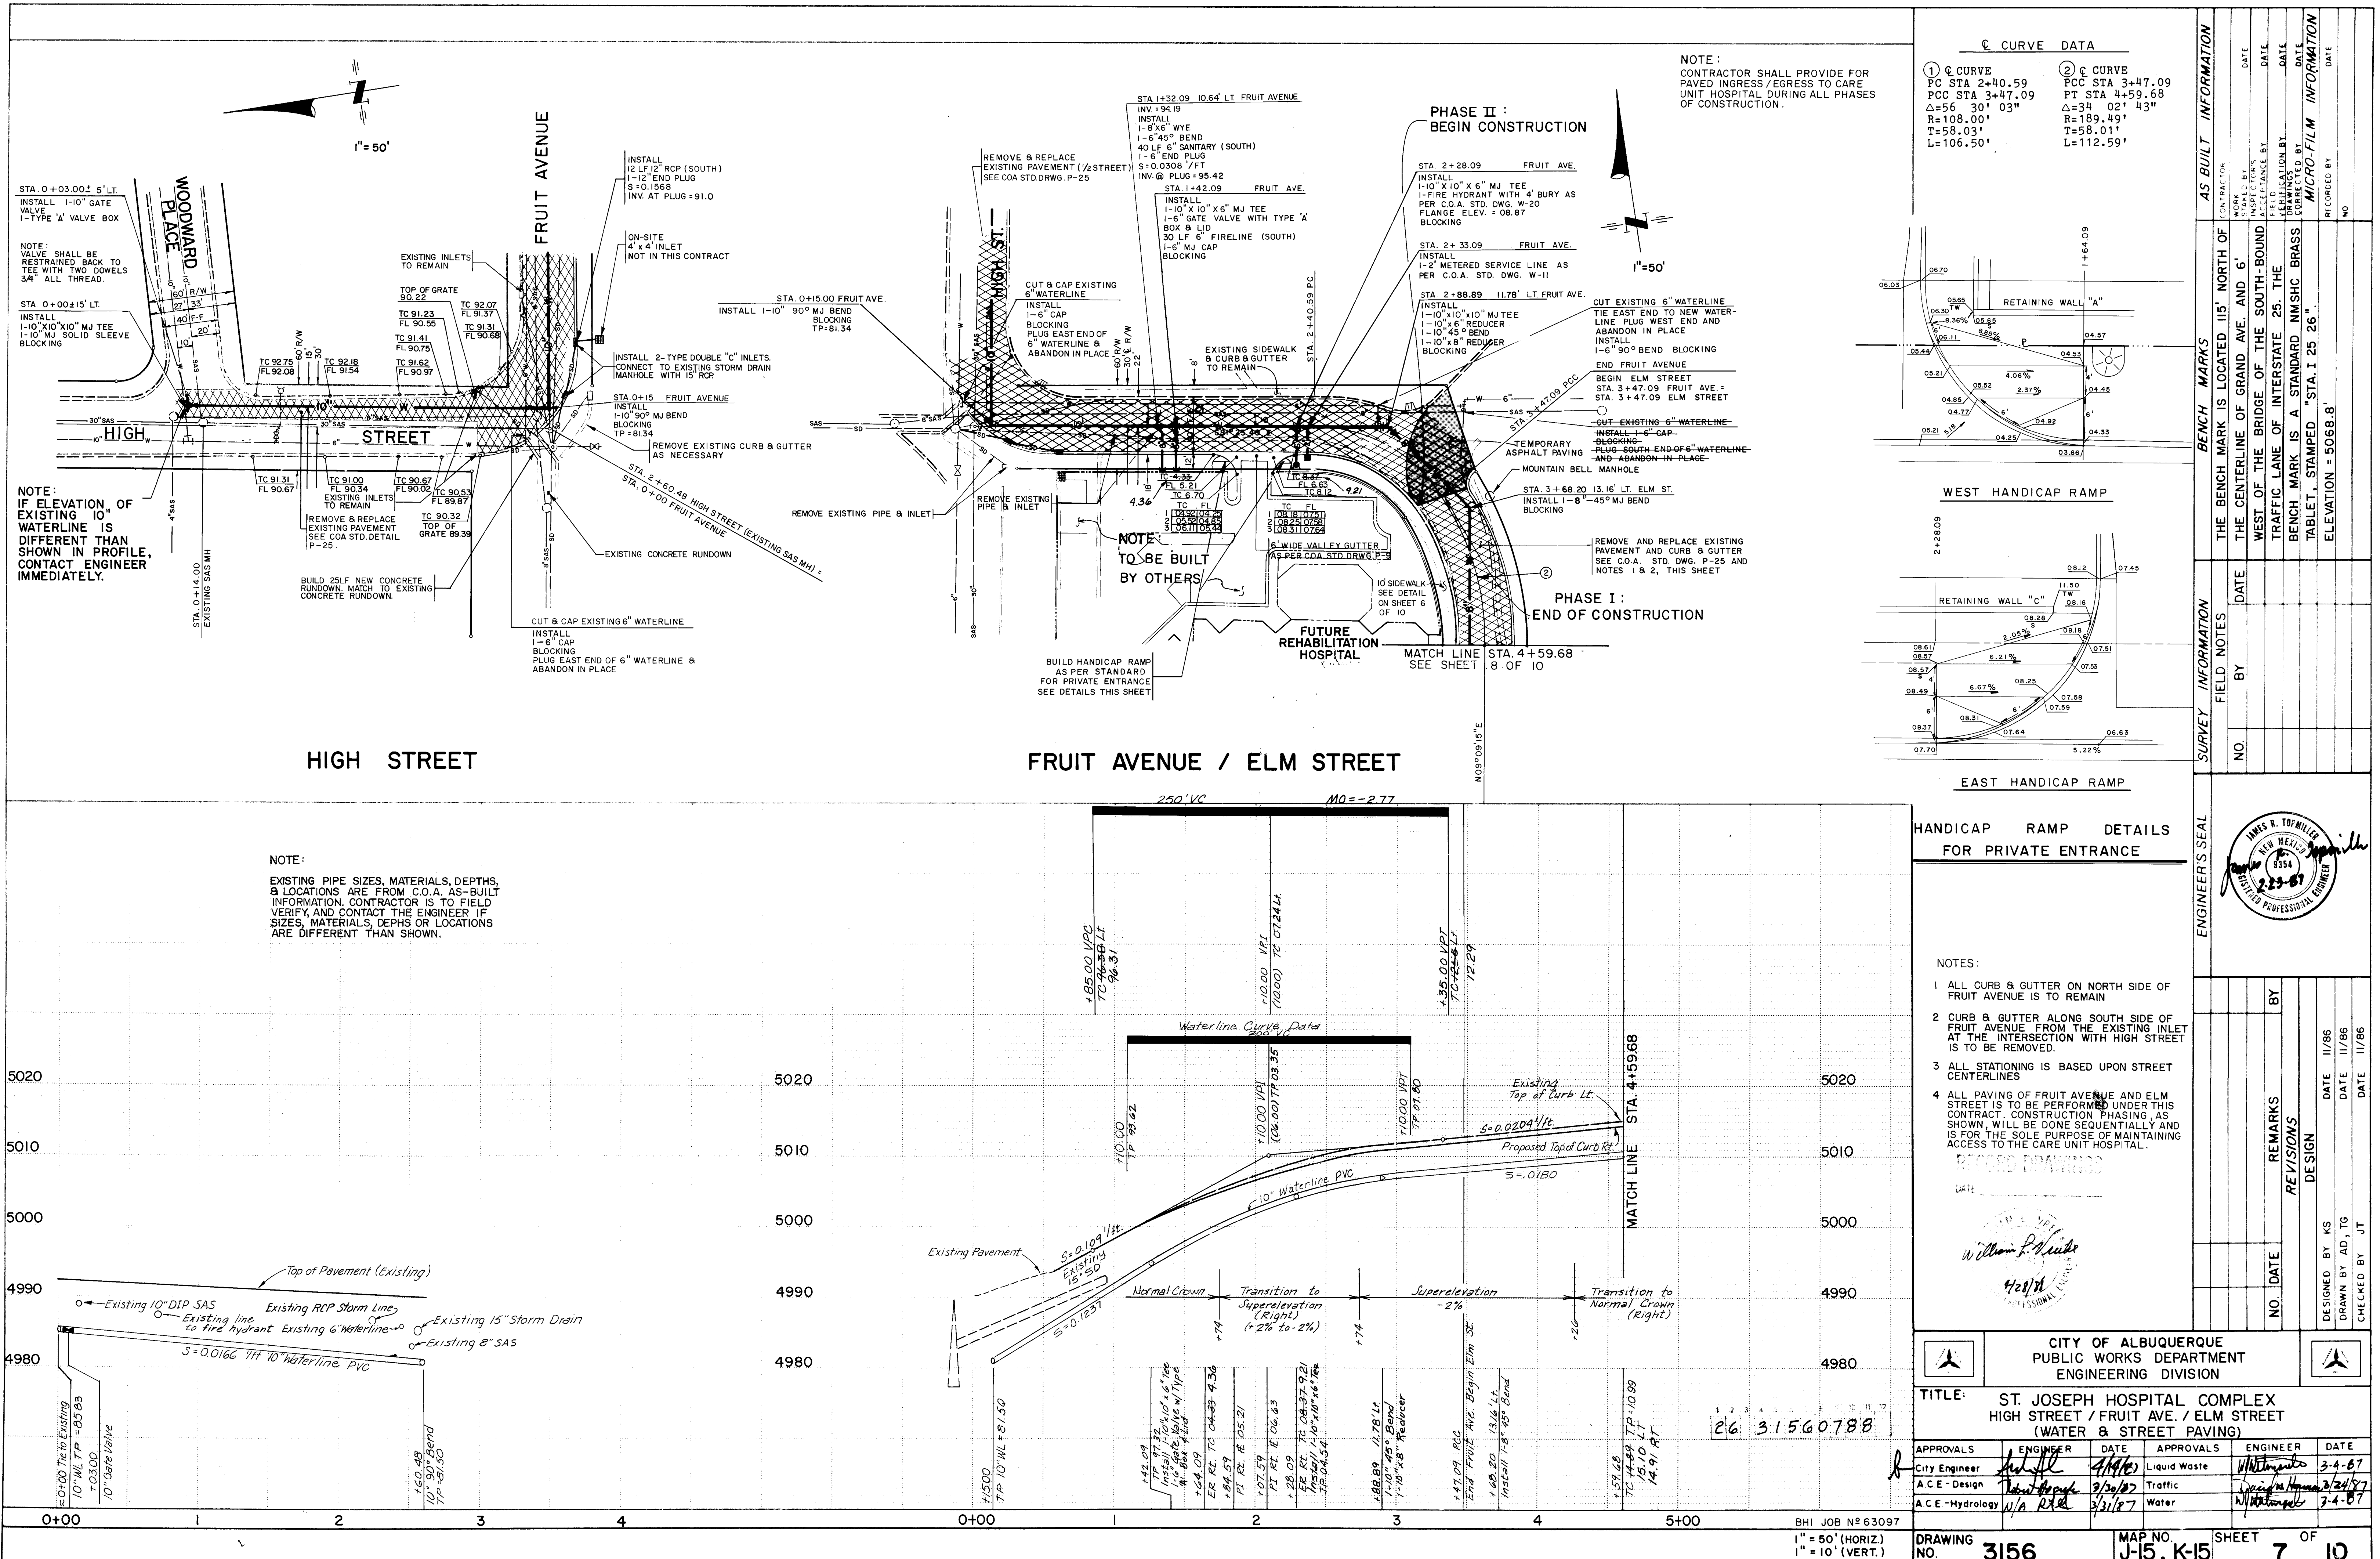




 NOTE :
FROM STATION 9+76.54 ~~20' RT.~~
TO STATION 11+92.86 ~~21.99' RT.~~
ELM STREET TRANSITIONS FROM
40' FF TO 43.98' FF.

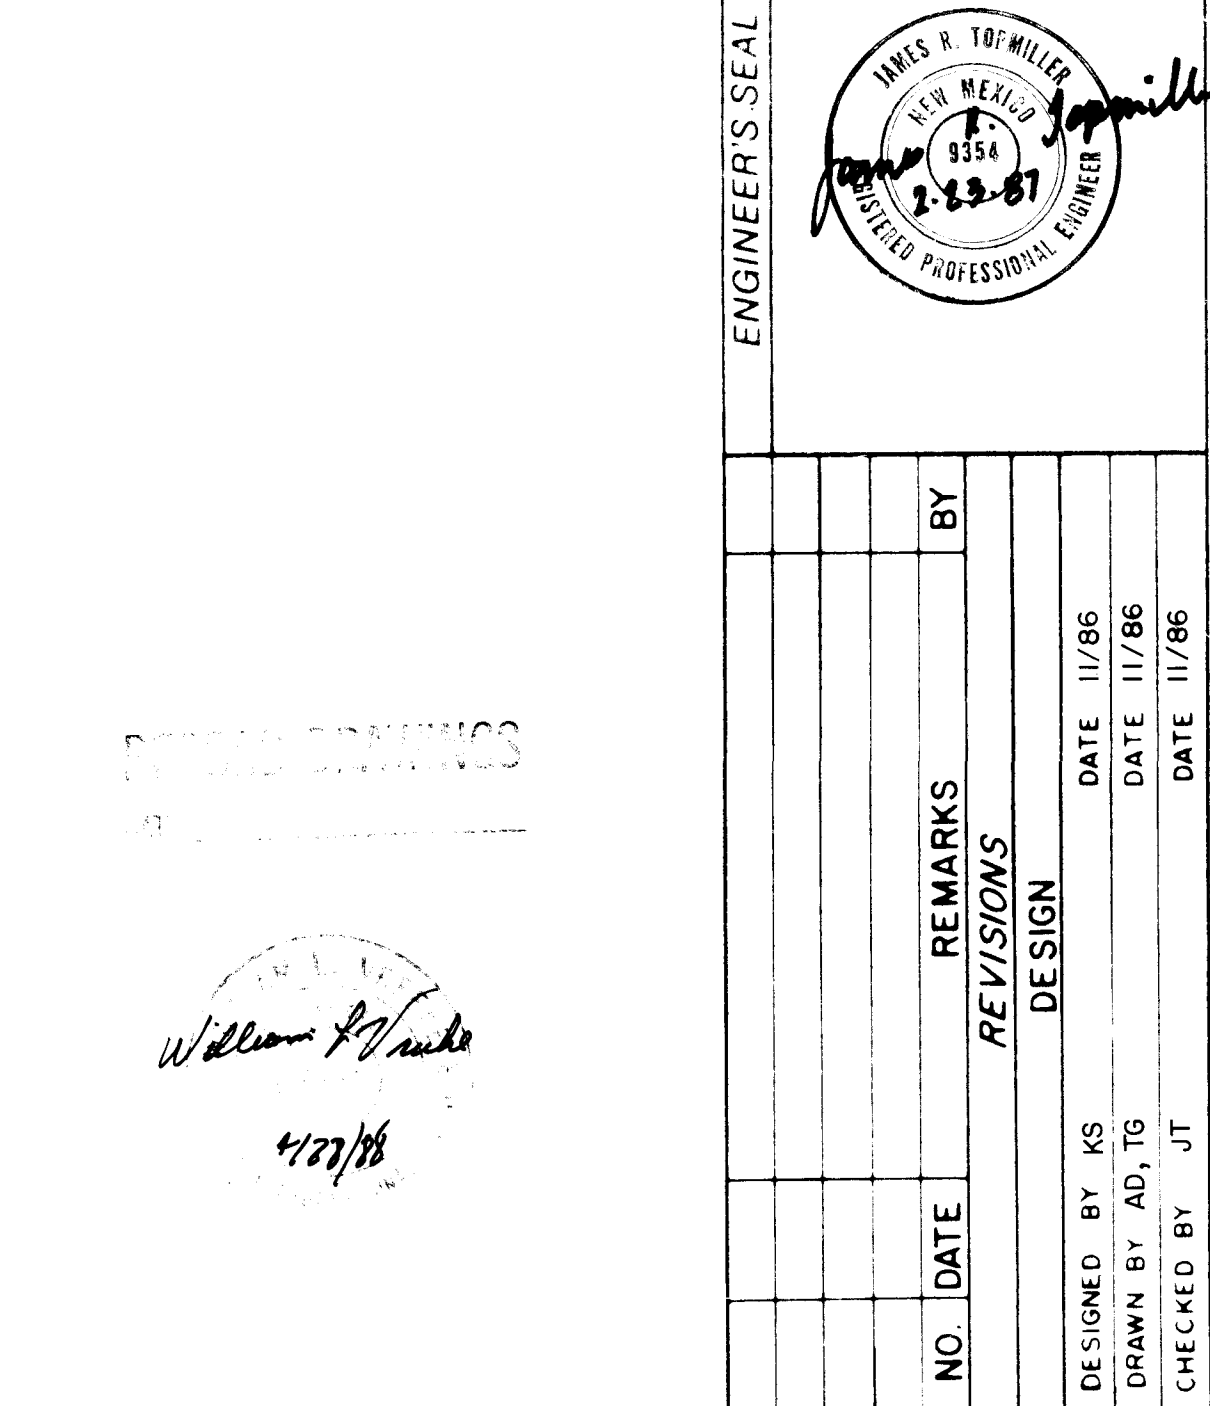

		CITY OF ALBUQUERQUE PUBLIC WORKS DEPARTMENT ENGINEERING DIVISION			
TITLE: ST. JOSEPH HOSPITAL COMPLEX ELM STREET (WATER & STREET PAVING)					
APPROVALS	ENGINEER	DATE	APPROVALS	ENGINEER	DATE
City Engineer	<i>[Signature]</i>	4/14/87	Liquid Waste	<i>[Signature]</i>	3-4-87
C-E-Design	<i>[Signature]</i>	3/26/87	Traffic	<i>[Signature]</i>	3-24-87
C-E-Hydrology	N/A R/S	3/31/87	Water	<i>[Signature]</i>	3-4-87
DRAWING NO.		MAP NO.		SHEET OF	
3156		J-15, K-15		8 10	

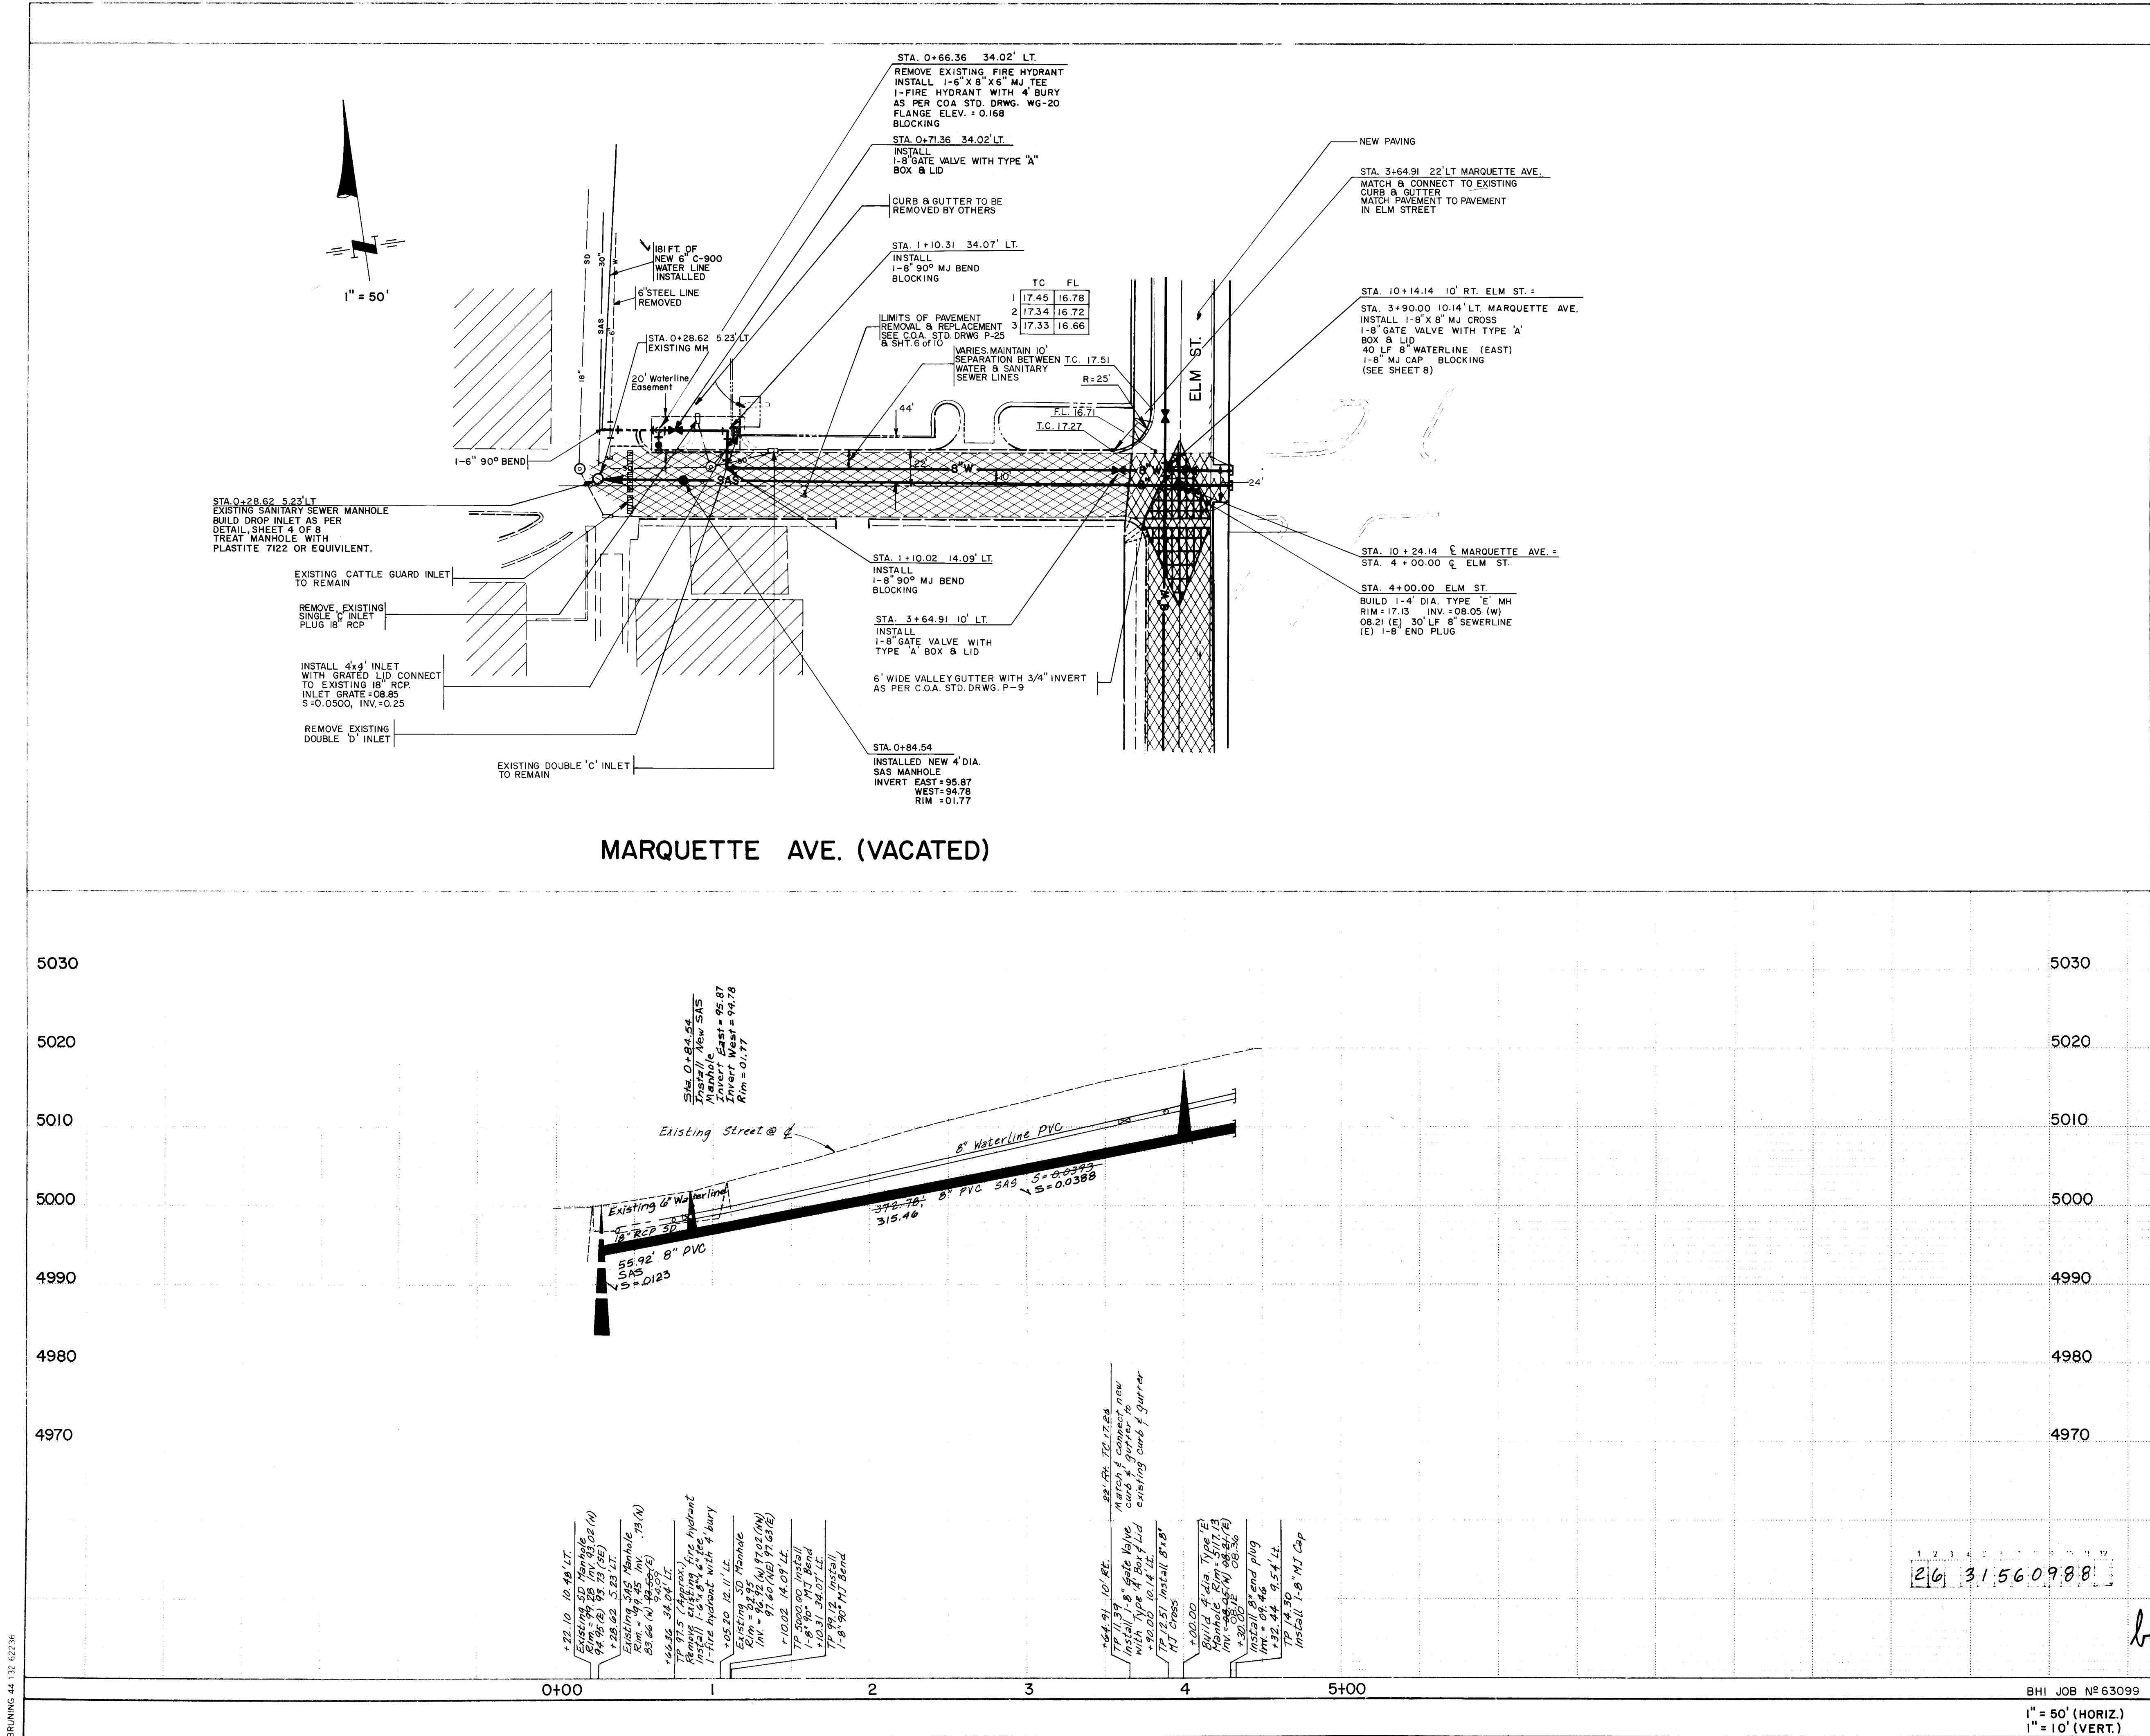

AS BUILT INFORMATION		BENCH MARKS		SURVEY INFORMATION		ENGINEER'S SEAL	
CONTRACT NO.	DATE	THE BENCH MARK IS LOCATED 115' NORTH OF THE CENTERLINE OF GRAND AVE. AND 6' WEST OF THE BRIDGE OF THE SOUTH-BOUND TRAFFIC LANE OF INTERSTATE 25. THE BENCH MARK IS A STANDARD MNHSC BRASS TABLET, STAMPED "STA 1-25-26" ELEVATION = 5068.8	NO.	BY	DATE	REMARKS	BY
						DESIGNED BY KS	DATE 11/86
						DRAWN BY TG, AD	DATE 11/86
						CHECKED BY JT	DATE 11/86

REVISIONS			
NO.	DATE	REVISIONS	BY
1	11/86	DESIGN	

RECORD DRAWINGS

DATE

CITY OF ALBUQUERQUE
PUBLIC WORKS DEPARTMENT
ENGINEERING DIVISION

TITLE: ST. JOSEPH HOSPITAL COMPLEX
MARQUETTE AVENUE (VACATED)
(WATER, SANITARY SEWER, STREET PAVING, & STORM DRAIN)

APPROVALS	ENGINEER	DATE	APPROVALS	ENGINEER	DATE
City Engineer	<i>[Signature]</i>	4/14/87	Liquid Waste	<i>[Signature]</i>	3-4-87
A C E - Design	<i>[Signature]</i>	2/20/87	Traffic	<i>[Signature]</i>	3-24-87
A C E - Hydrology	<i>[Signature]</i>	3/3/87	Water	<i>[Signature]</i>	3-4-87



BHI JOB N° 63099

DRAWING NO. 3156

MAP NO. J-15, K-15

SHEET 9 OF 10

- NOTE:
- EXISTING PIPE SIZES, MATERIALS, DEPTHS AND LOCATIONS ARE FROM C.O.A. AS-BUILT INFORMATION. CONTRACTOR IS TO FIELD VERIFY, AND CONTACT THE ENGINEER IF SIZES, MATERIALS, DEPTHS OR LOCATIONS ARE DIFFERENT THAN SHOWN.
 - THE 6 LF OF PVC 8" D.I.P. WATERLINE SHOWN IS MEASURED FROM THE CENTER OF THE EXISTING WATERLINES TO THE CENTER OF THE 90° BEND. THE ACTUAL AMOUNT OF MATERIAL REQUIRED WILL BE LESS.

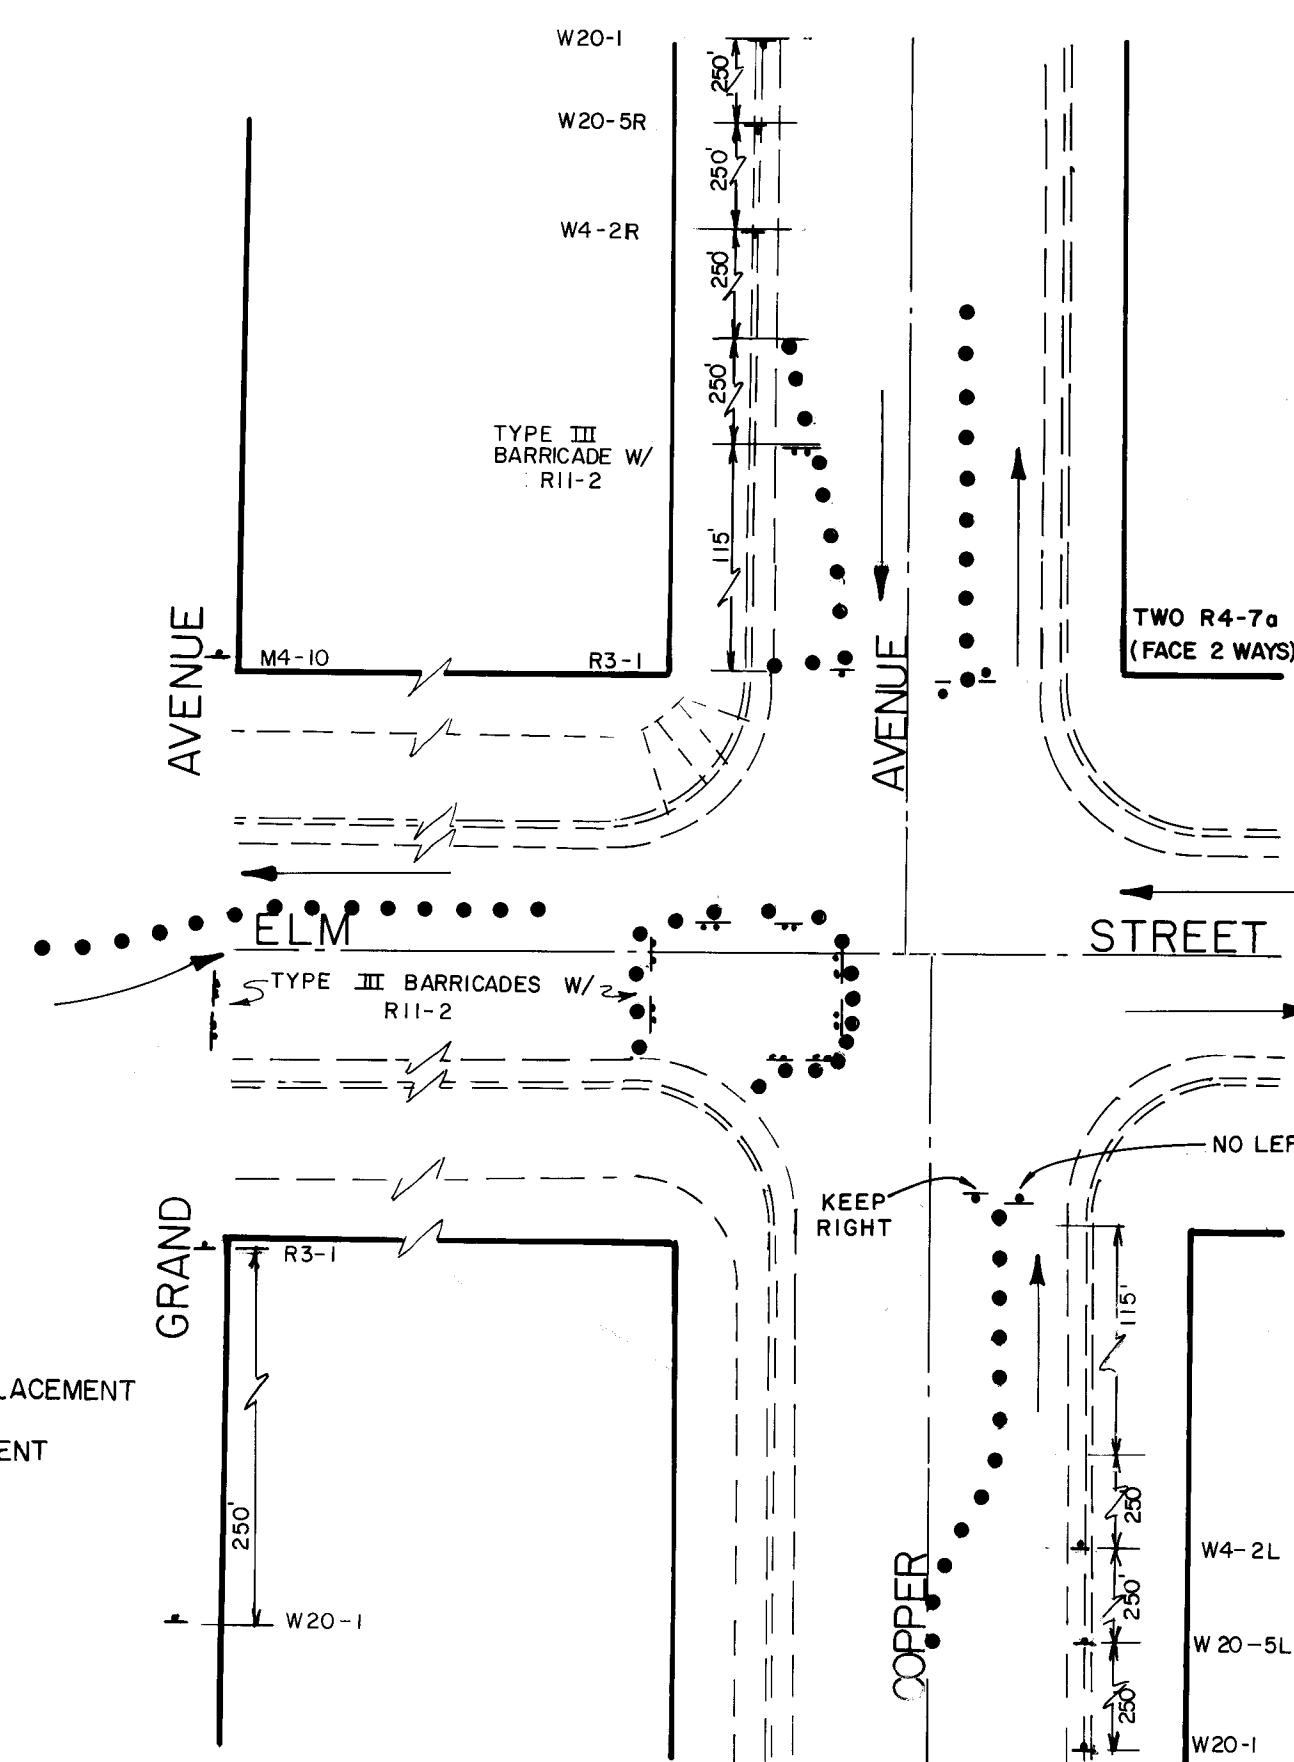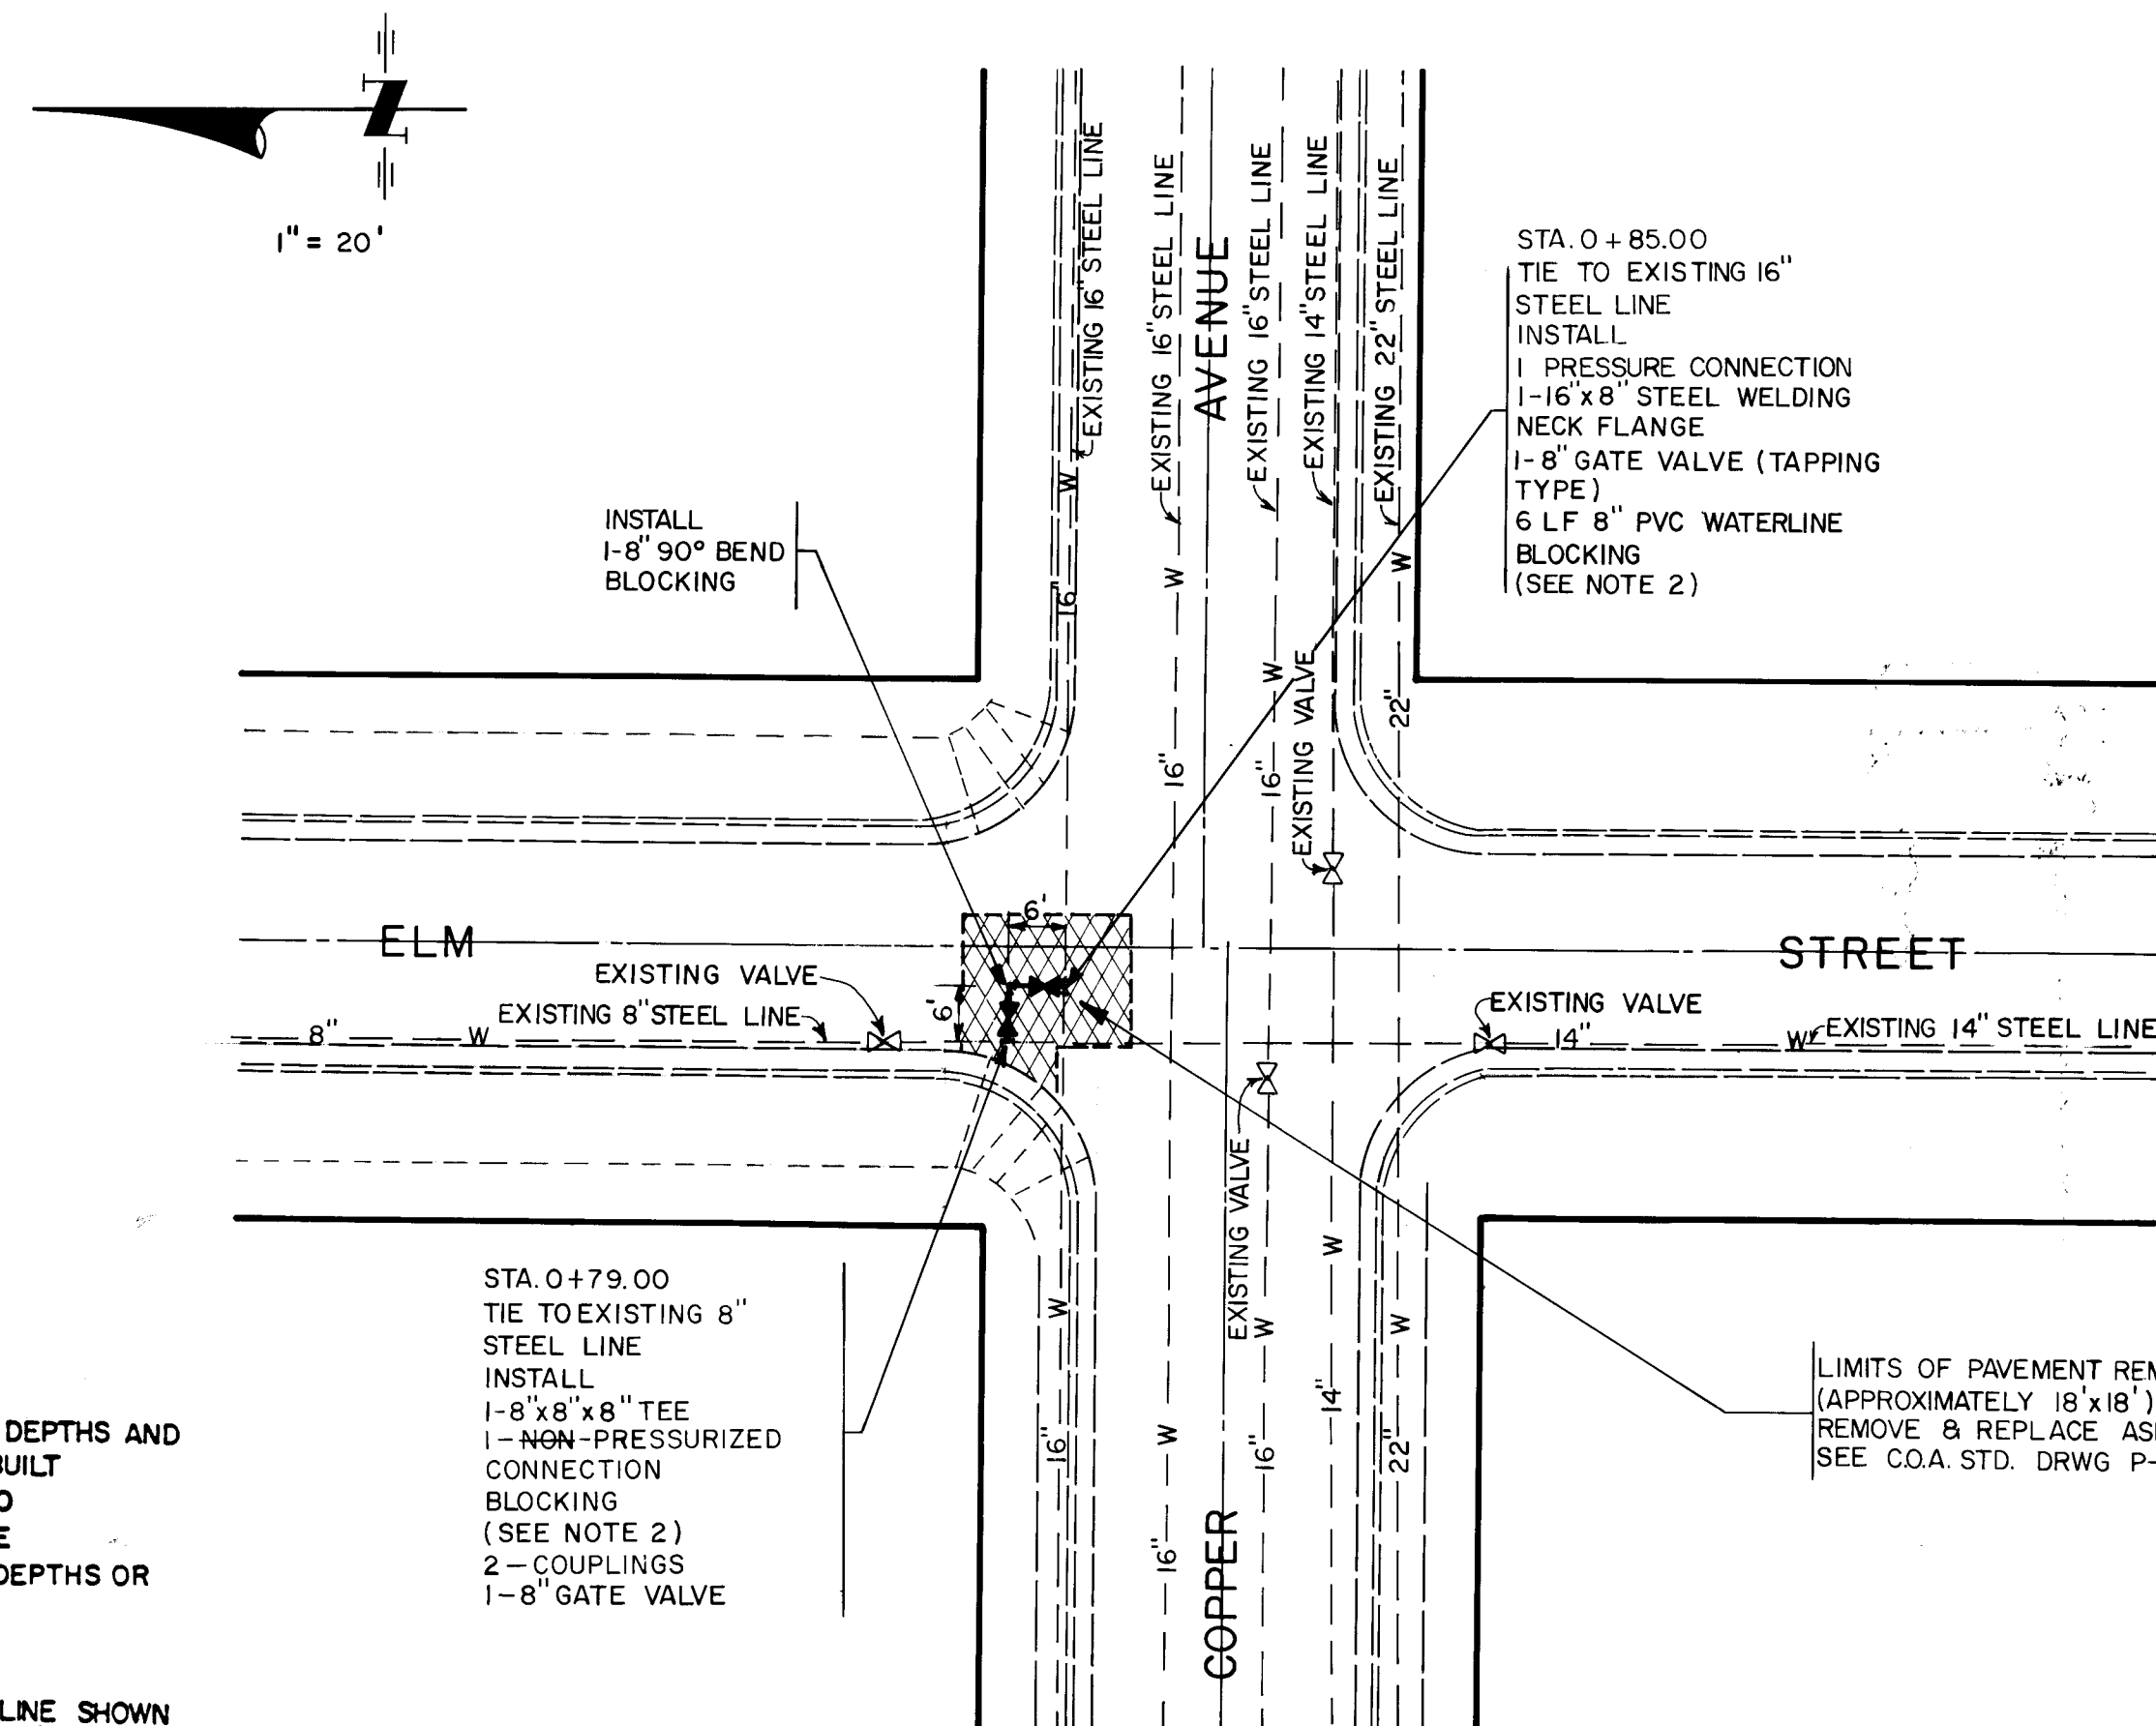

TRAFFIC CONTROL PLAN

NOT TO SCALE


NOTE:
GUIDANCE FOR THIS TRAFFIC
CONTROL PLAN WAS PROVIDED
BY RAY ALDERETE, C.O.A.
TRAFFIC SAFETY. ANY QUES-
TIONS, CALL HIM AT 768-2788

NOTE:
SEE TYPICALS FOR ADVANCED
SIGNING AND CHANNELIZATION

LEGEND

- BARRELS
- ▲ TYPE III BARRICADE
- △ SIGN

SIGNS

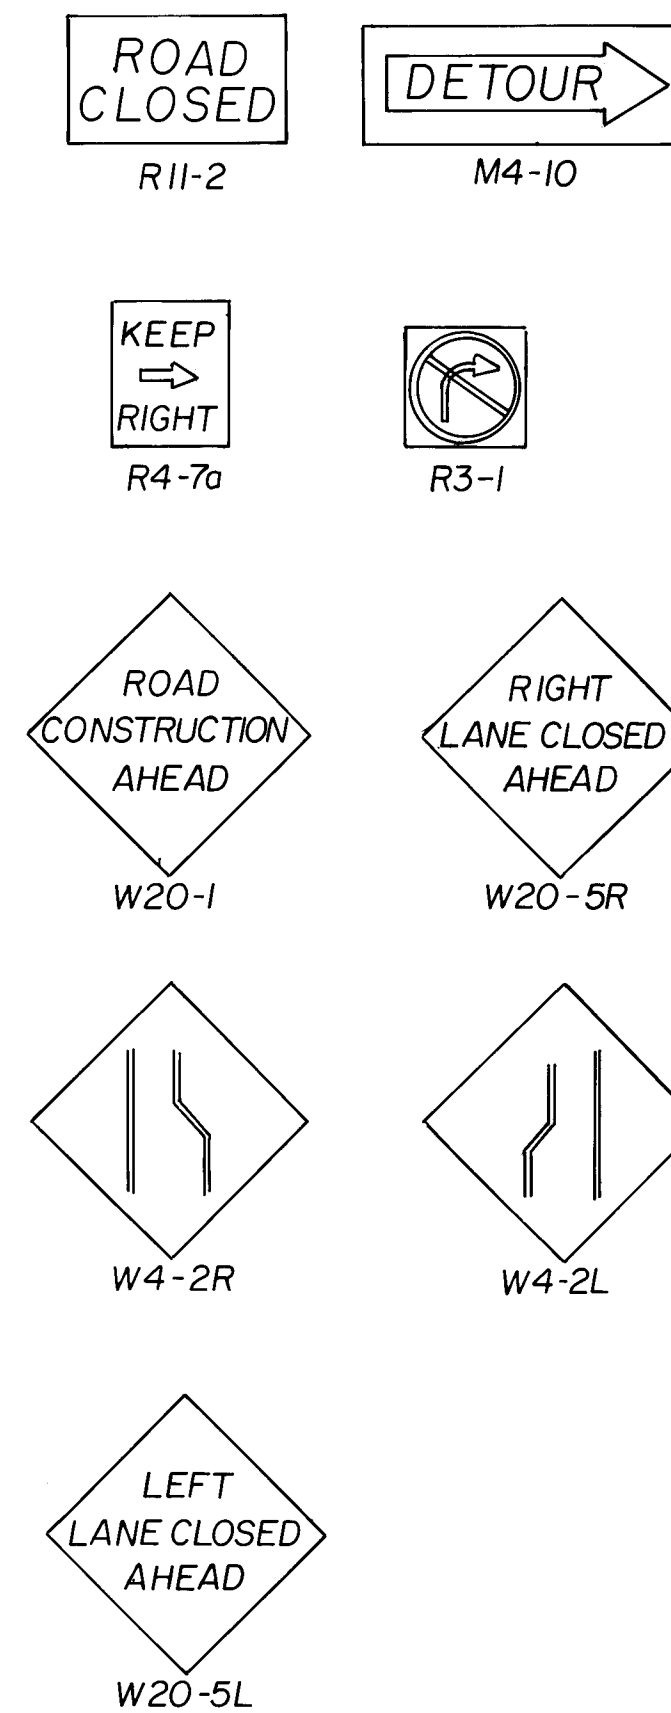

NOTE:

- CONTRACTOR SHALL COMPLY WITH SECTION 19 OF THE INTERIM STANDARD SPECIFICATION FOR PUBLIC WORKS CONSTRUCTION FOR THE CITY OF ALBUQUERQUE.
- CONTRACTOR MUST MAINTAIN ACCESS TO ALL BUSINESS AT ALL TIMES.
- CONTRACTOR SHALL REMOVE AND REPLACE ALL PAVEMENT STRIPPING THAT WOULD CONFLICT WITH EXISTING DETOUR TRAFFIC.
- ALL CHANNELIZING DEVICES OF ADVANCED WARNING SIGNS MUST BE FITTED WITH TYPE "A" LIGHTING.
- PRIOR TO OCCUPYING THE ROADWAY, CONTRACTOR SHALL NOTIFY WITHIN 24 HOURS: POLICE, FIRE DEPARTMENT, BUSINESS AFFECTED BY CONSTRUCTION, AND PUBLIC TRANSPORTATION.
- CONTRACTOR SHALL OBTAIN BARRICADING AND EXCAVATION PERMITS AND TYPICALS FROM BARRICADE ENGINEER 24 HOURS IN ADVANCE OF CONSTRUCTION.

RECORD DRAWING

4/23/88



CITY OF ALBUQUERQUE
PUBLIC WORKS DEPARTMENT
ENGINEERING DIVISION

TITLE: ST. JOSEPH HOSPITAL COMPLEX
COPPER AVENUE / ELM STREET
WATER CONNECTION

APPROVALS	ENGINEER	DATE	APPROVALS	ENGINEER	DATE
City Engineer	W. J. Williams	4/14/87	Liquid Waste	W. J. Williams	3-4-87
A.C.E. - Design	W. J. Williams	3/29/87	Traffic	W. J. Williams	3-24-87
A.C.E. - Hydrology	W. J. Williams	3/24/87	Water	W. J. Williams	3-24-87

DRAWING NO.	3156	MAP NO.	J-15, K-15	SHEET	10	OF	10
-------------	------	---------	------------	-------	----	----	----

BHI JOB #63098

1" = 20' (HORIZ.)
1" = 5' (VERT.)

AS BUILT INFORMATION		BENCH MARKS		SURVEY INFORMATION		ENGINEER'S SEAL		REVISIONS		DESIGN	
CONTRACT NO.	DATE	THE BENCH MARK IS LOCATED 115' NORTH OF THE CENTERLINE OF GRAND AVE. AND 6' WEST OF THE BRIDGE OF THE SOUTH-BOUND TRAFFIC LANE OF INTERSTATE 25. THE BENCH MARK IS A STANDARD NMSHC BRASS TABLET, STAMPED "STA 1-25-26". ELEVATION = 5068.8	NO.	BY	DATE	NO.	DATE	NO.	DATE	DESIGNED BY	CHECKED BY
										KS	JT

