
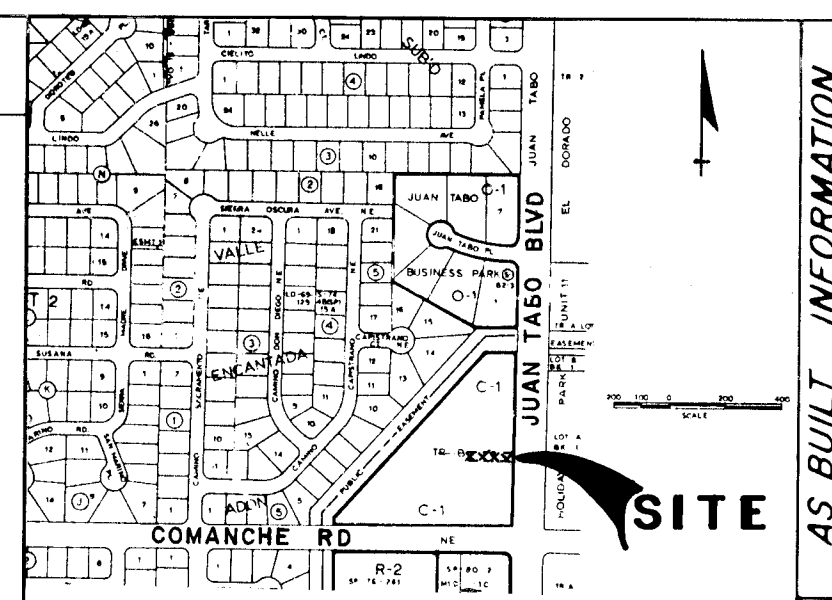
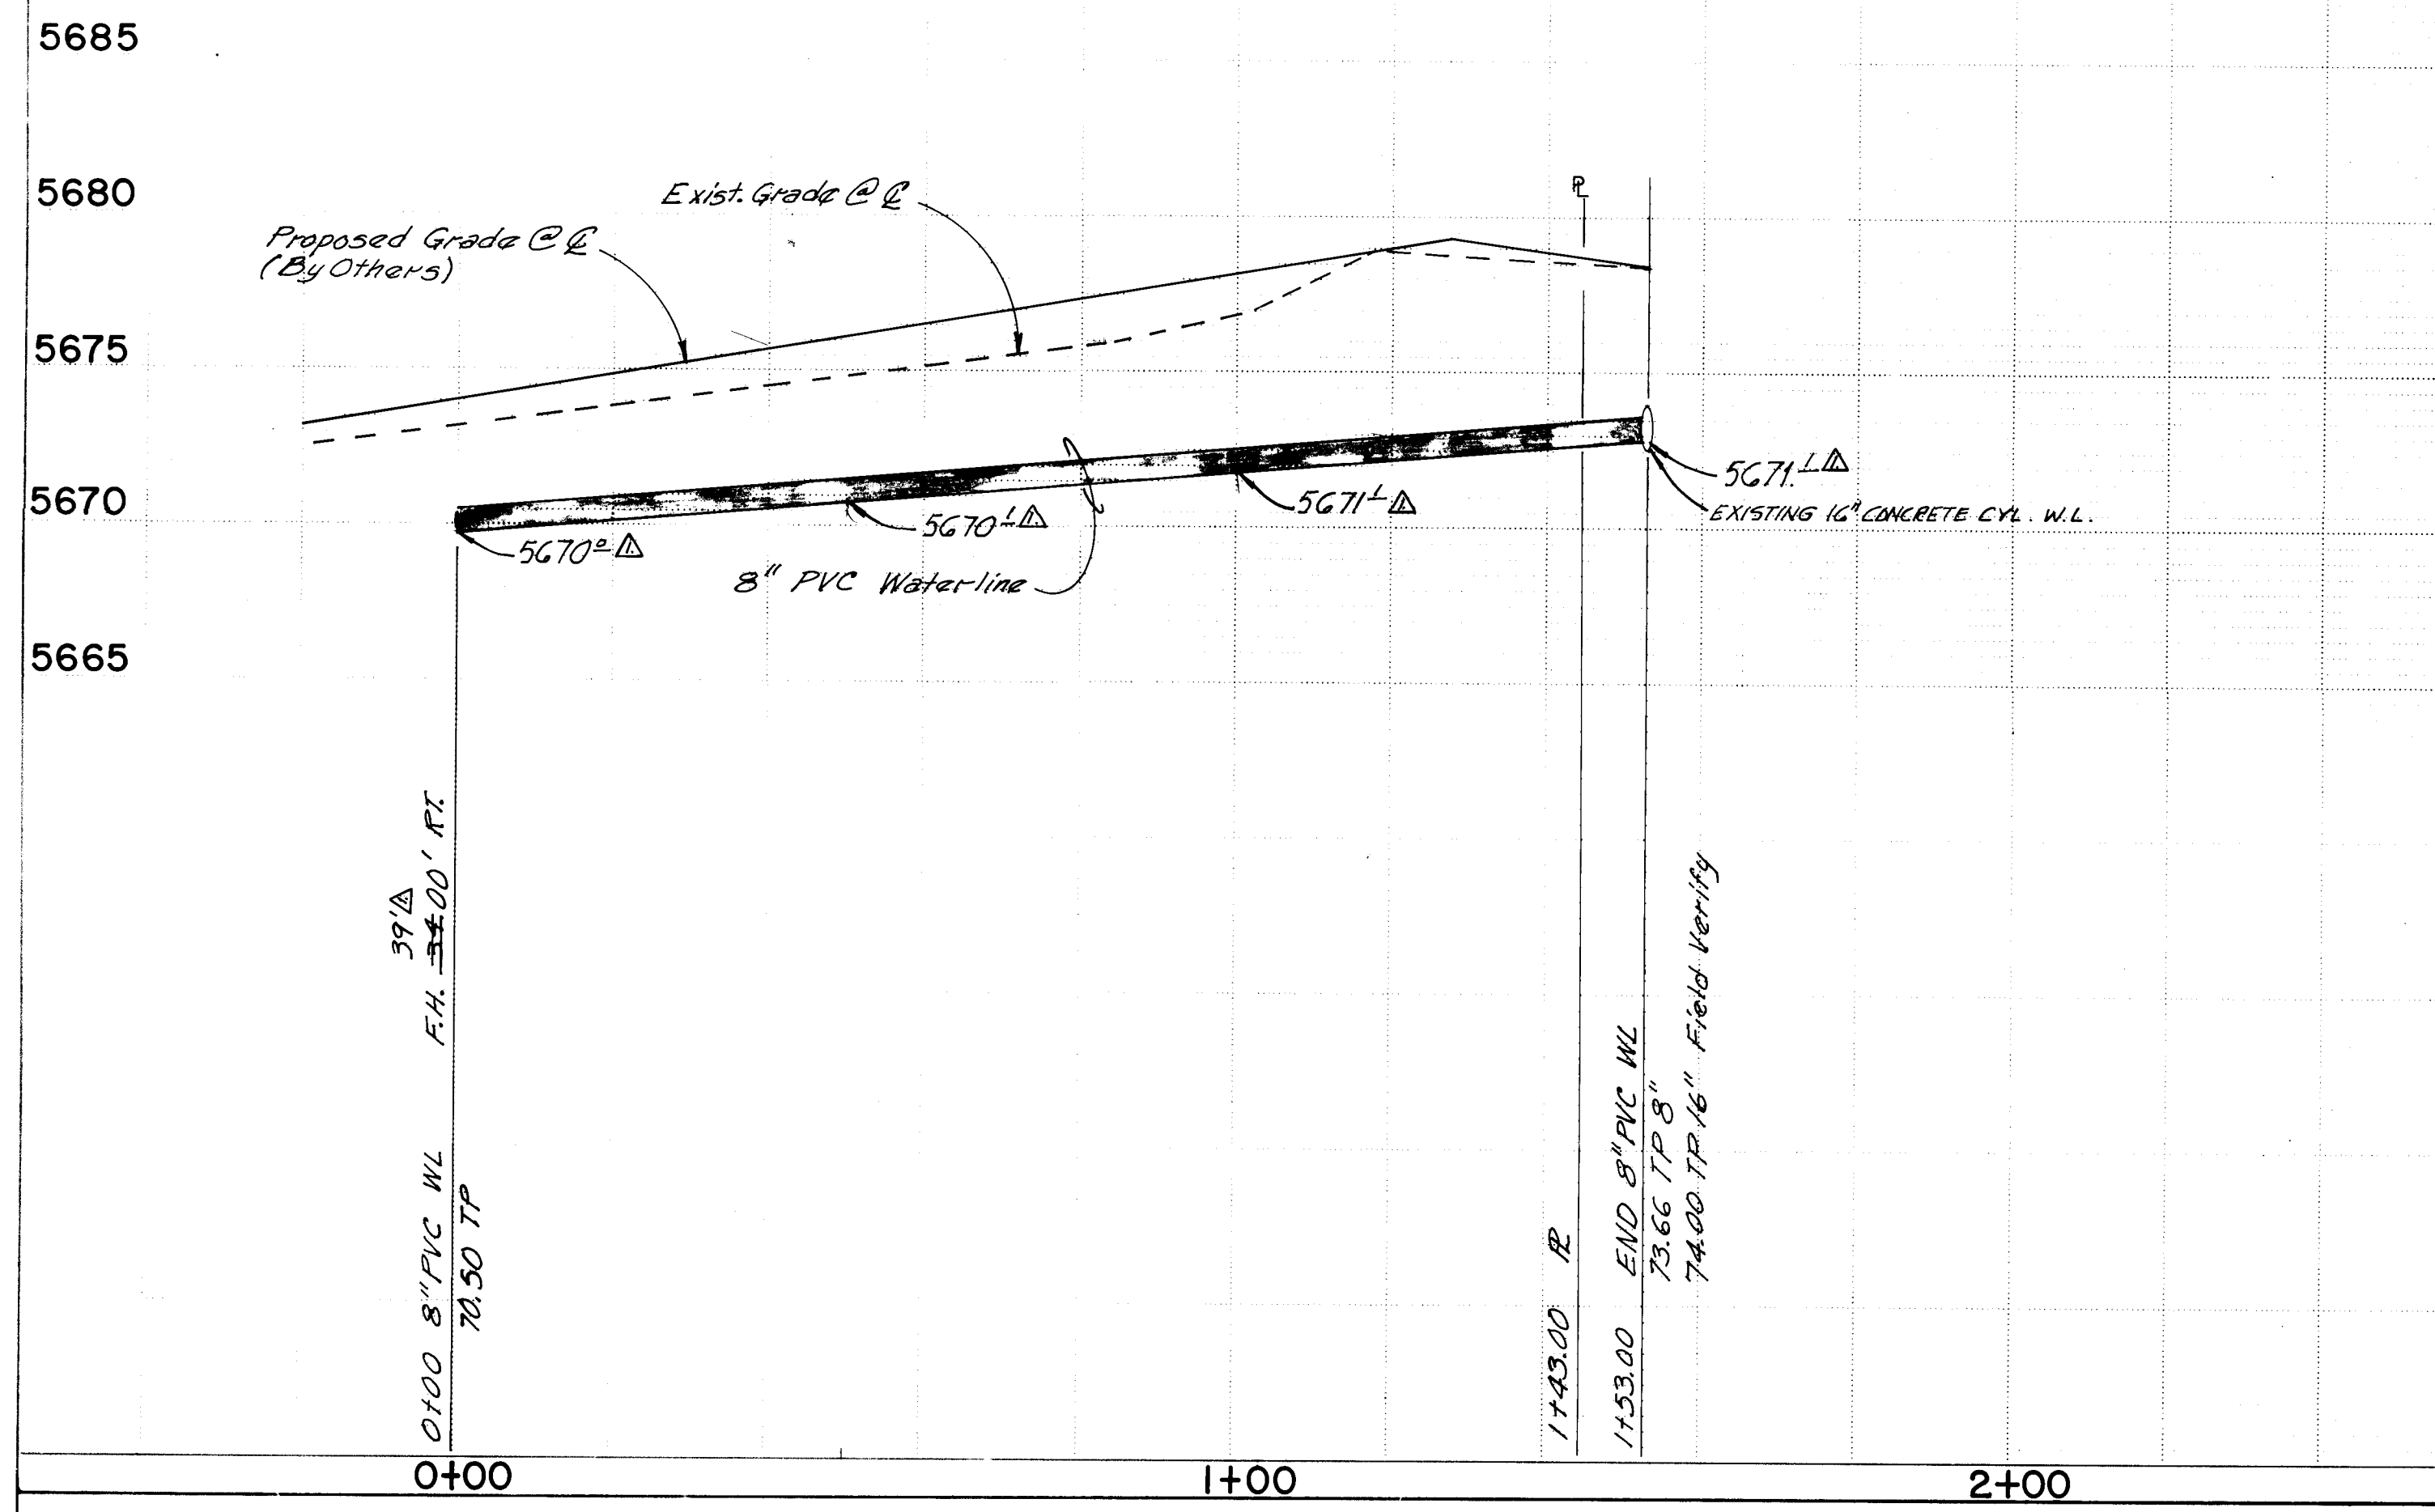


KEYED NOTE:  
1. THIS CONNECTION SHALL COMPLY WITH SECTION 128, CITY OF ALBUQUERQUE, INTERIM STANDARD SPECIFICATIONS, PUBLIC WORKS CONSTRUCTION, 1985. CONTRACTOR SHALL COORDINATE THE CONNECTION WITH THE WATER SYSTEMS DIVISION BEFORE COMMENCING WORK. THE WATER SYSTEMS DIVISION SHALL INSPECT AND APPROVE THE ENTIRE OPERATION OF THE TAP.

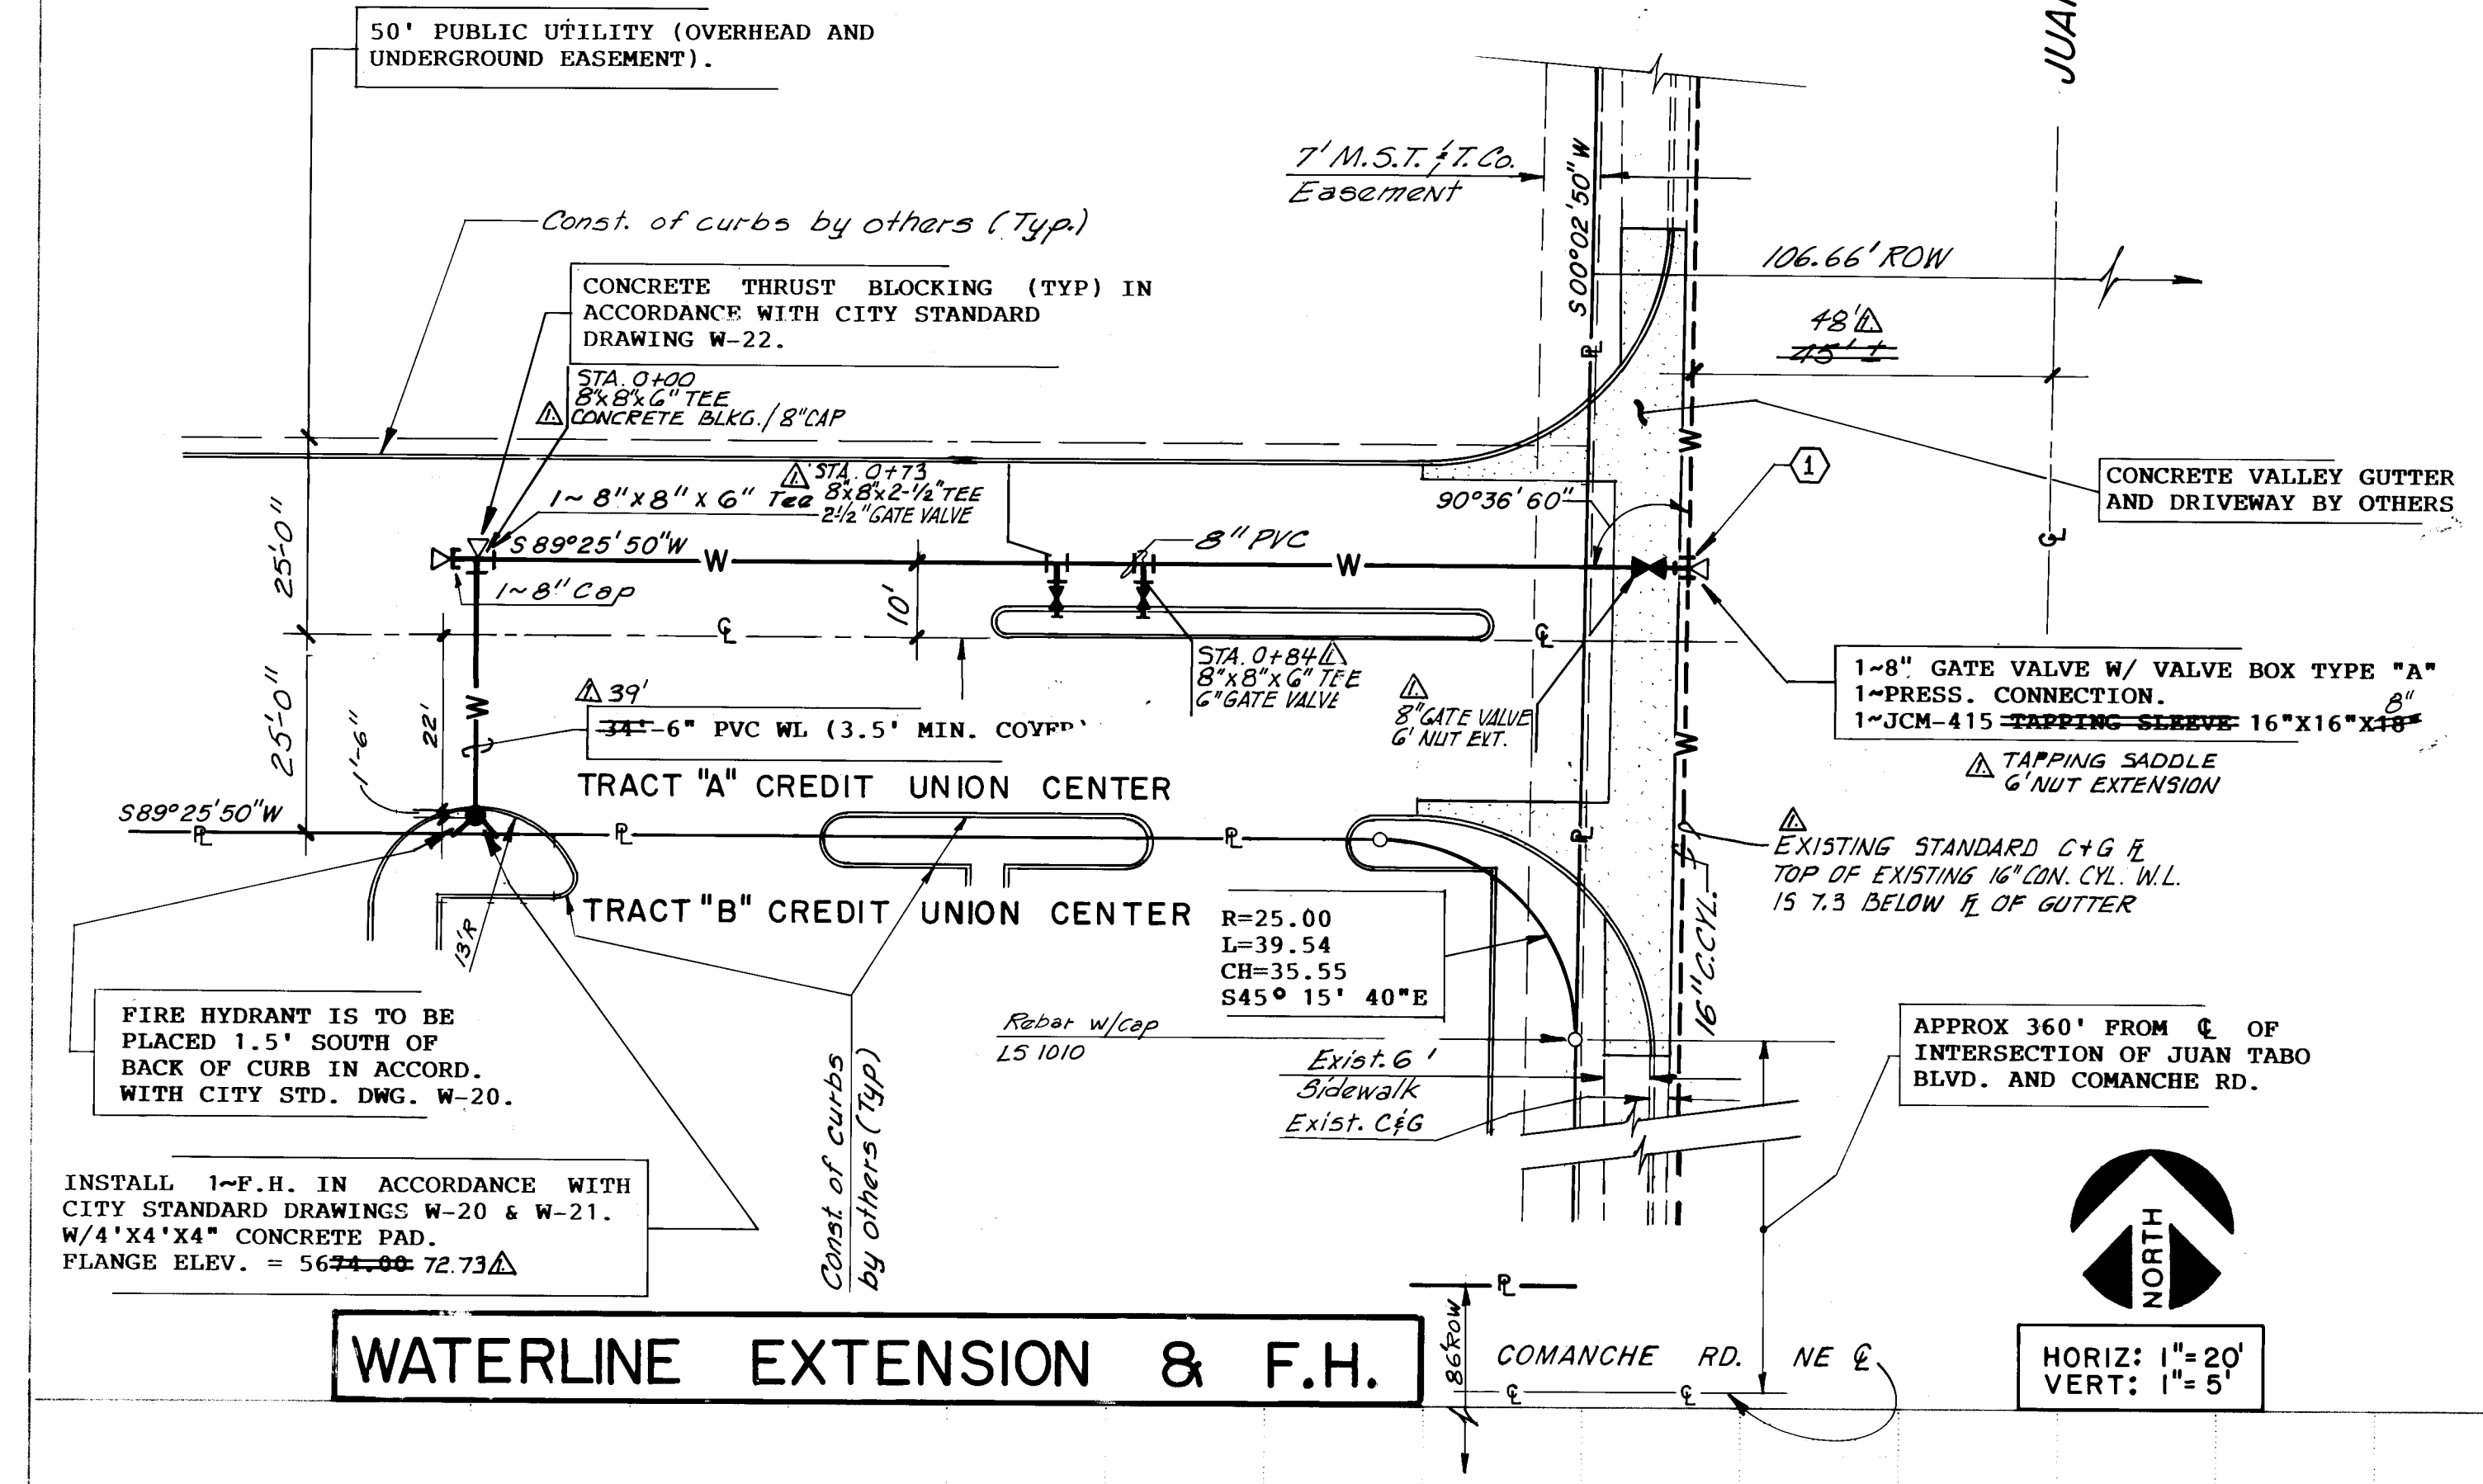

VICINITY MAP G-21-Z

NOTICE TO CONTRACTOR

1. ALL WORK DETAILED ON THESE PLANS TO BE PERFORMED, EXCEPT AS OTHERWISE STATED OR PROVIDED HEREON, SHALL BE CONSTRUCTED IN ACCORDANCE WITH THE CITY OF ALBUQUERQUE INTERIM STANDARD SPECIFICATIONS FOR PUBLIC WORKS CONSTRUCTION, 1985. ALL WORK ON THIS PROJECT SHALL BE PERFORMED IN ACCORDANCE WITH APPLICABLE FEDERAL, STATE AND LOCAL LAWS, RULES AND REGULATIONS CONCERNING CONSTRUCTION SAFETY AND HEALTH.
2. TWO WORKING DAYS PRIOR TO ANY EXCAVATION, CONTRACTOR MUST CONTACT LINE LOCATING SERVICE, 765-1234, FOR LOCATION OF EXISTING UTILITIES.
3. PRIOR TO CONSTRUCTION, THE CONTRACTOR SHALL EXCAVATE AND VERIFY THE HORIZONTAL AND VERTICAL LOCATIONS OF ALL POTENTIAL OBSTRUCTIONS. SHOULD A CONFLICT EXIST, THE CONTRACTOR SHALL NOTIFY THE ENGINEER SO THAT THE CONFLICT CAN BE RESOLVED WITH A MINIMUM AMOUNT OF DELAY.
4. CONTRACTOR IS RESPONSIBLE FOR EROSION CONTROL DURING THE CONSTRUCTION PHASE, INCLUDING ANY PROVISIONS THAT NEED TO BE TAKEN TO DIVERT ANY SEDIMENT FROM ENTERING THE CITY RIGHT-OF-WAY, I.E., WINDROWS, SILT FENCING, OR APPROVED EQUAL.
5. CONTRACTOR SHALL ASSIST THE ENGINEER/INSPECTOR IN THE RECORDING OF DATA ON ALL UTILITY LINES AND ACCESSORIES AS REQUIRED BY THE CITY OF ALBUQUERQUE FOR THE PREPARATION OF "AS CONSTRUCTED" DRAWINGS. CONTRACTOR SHALL NOT COVER UTILITY LINES AND ACCESSORIES UNTIL ALL DATA HAS BEEN RECORDED.
6. REFERENCE MADE TO STANDARD DRAWINGS REFER TO ALBUQUERQUE STANDARD DRAWINGS.
7. CURB AND GUTTER SHOWN AS EXISTING AND NOT TO BE REMOVED UNDER THE CONTRACT WHICH IS DAMAGED OR DISPLACED BY THE CONTRACTOR SHALL BE REMOVED AND REPLACED BY THE CONTRACTOR AT HIS EXPENSE.
8. WHEN CONSTRUCTION UNDER THIS PROJECT CONNECTS TO EXISTING IMPROVEMENTS, THE CONTRACTOR SHALL PROVIDE AN EASY RIDING CONNECTION.

APPROVAL OF AS BUILT DRAWINGS  
AS A CITY ENGINEER-FIELD  
*Prison F. Smith*  
DATE 6/29/87

*John W. Hunsley* 6/29/87

CITY OF ALBUQUERQUE MUNICIPAL DEVELOPMENT DEPARTMENT ENGINEERING DIVISION					
TITLE: 3750 JUAN TABO BLVD. NE WATERLINE EXTENSION - PLAN & PROFILE & NEW FIRE HYDRANT					
APPROVALS	ENGINEER	DATE	APPROVALS	ENGINEER	DATE
City Engineer	<i>Prison F. Smith</i>	6/29/87	Liquid Waste	<i>WJH</i>	3-26-87
A C E - Design	"	"	Traffic	<i>WJH</i>	3-30-87
A C E - Hydrology	"	"	Water	<i>WJH</i>	3-26-87

REVISIONS		DESIGN	
NO.	DATE	BY	DATE
1	6-18-87	REVISION FROM AS BUILT INFORMATION	DESIGNED BY JSM
2	6-29-87	REVISIONS	DRAWN BY JJC
3	6-29-87	REVISIONS	CHECKED BY JJC

DRAWING NO. 3198	MAP NO. G-21-Z	SHEET 1 OF 1
------------------	----------------	--------------