


CITY OF ALBUQUERQUE, NEW MEXICO
PUBLIC WORKS DEPARTMENT

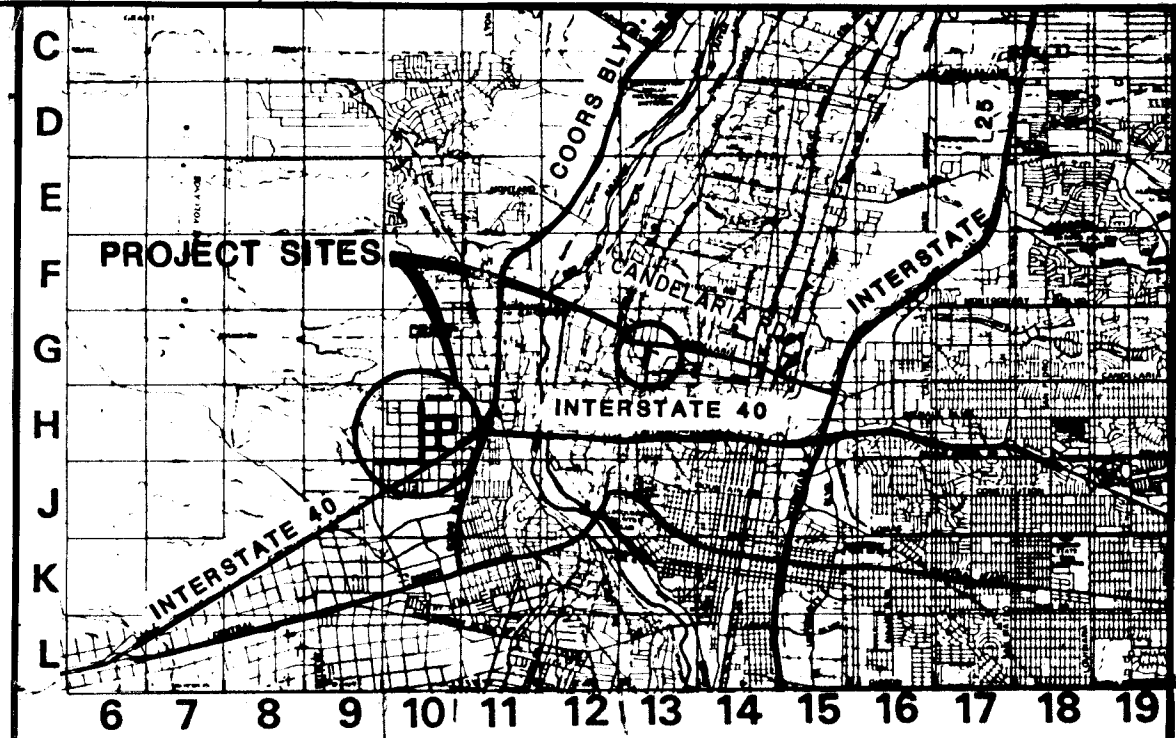

**STREET IMPROVEMENTS
SPECIAL ASSESSMENT DISTRICT NO. 218**

NOTES

ALL WORK DETAILED ON THESE PLANS TO BE PERFORMED UNDER CONTRACT SHALL, EXCEPT AS OTHERWISE STATED OR PROVIDED FOR HEREON, BE CONSTRUCTED IN ACCORDANCE WITH THE C.O.A. STANDARD SPECIFICATIONS FOR PUBLIC WORKS CONSTRUCTION - 1986 EDITION (REFERRED TO HEREIN AS THE STANDARD SPECIFICATIONS).

TWO (2) WORKING DAYS PRIOR TO ANY EXCAVATION, CONTRACTOR MUST CONTACT LINE LOCATING SERVICE, 765-1234, FOR LOCATION OF EXISTING UTILITIES

PRIOR TO CONSTRUCTION, THE CONTRACTOR SHALL EXCAVATE AND VERIFY THE HORIZONTAL AND VERTICAL LOCATIONS OF ALL OBSTRUCTIONS. SHOULD A CONFLICT EXIST, THE CONTRACTOR SHALL NOTIFY THE ENGINEER OR SURVEYOR SO THAT THE CONFLICT CAN BE RESOLVED WITH MINIMUM AMOUNT OF DELAY.

INDEX	Sheet No.
COVER SHEET & INDEX OF SHEETS	1
GENERAL NOTES	2
LOCATION MAPS	3
TRAFFIC CONTROL PLAN	4
HANOVER	
Paving	5 - 8
Water	9 - 12
Sanitary Sewer	13 - 15
ILIFF	
Paving	16 - 17
Water	18 - 19
Sanitary Sewer	20 - 21
Storm Drain	22
JUNIPER	
Paving	23 - 24
Water	25 - 26
Sanitary Sewer	27 - 28
Storm Drain	29
72ND	
Paving	30 - 33
Water	34 - 35
Storm Drain	36
68TH	
Paving	37 - 38
Water	39 - 40
Sanitary Sewer	41 - 42
Storm Drain	43
64TH	
Paving	44
Water	45
Sanitary Sewer	46
Storm Drain	47
INDIAN FARM LANE	
Paving	48
RETENTION POND	49
TYPICAL SECTION	50
LIGHTING PLAN	51
WATER SHUT OFF PLAN	52

APPROVAL OF AS BUILT DRAWINGS
CHIEF CONSTRUCTION ENGINEER
[Signature]
DATE 5/1/90

26 32290190



GARDNER, MASON & ASSOCIATES, INC.
ENGINEERS & PLANNERS
ALBUQUERQUE, N.M.

REV	SHEETS	CITY ENGR.	DATE	USER	DEPT.	DATE	USER	DEPT.	DATE
APPROVAL OF REVISIONS									

WILSON & COMPANY
ENGINEERS & ARCHITECTS
ALBUQUERQUE, NEW MEXICO

APPROVED FOR CONSTRUCTION
[Signature]
3-5-90

PROJECT No. 222


SHEET 1 OF 52

RECORD DRAWING
DATE 3-1-90

GENERAL NOTES


- ALL RADII OF CURB RETURNS ARE SHOWN TO FACE OF CURB.
- UNLESS OTHERWISE SHOWN, ALL DIMENSIONS ARE TO FACE OF CURB.
- ALL FINISH GRADES AND PROFILES SHOWN ARE TOP OF CURB GRADES, UNLESS OTHERWISE NOTED. MATCH FLOWLINES OF GUTTERS WHEN CONNECTING NEW CURB AND GUTTER TO EXISTING.
- ALL UTILITY POLES ARE TO BE RELOCATED BY OTHERS.
- CURB AND GUTTER SHOWN AS EXISTING AND NOT TO BE REMOVED UNDER THIS CONTRACT WHICH IS DAMAGED OR DISPLACED BY THE CONTRACTOR SHALL BE REMOVED AND REPLACED BY THE CONTRACTOR AT HIS EXPENSE.
- WHEN ABUTTING NEW PAVEMENT TO EXISTING, SAW CUT EXISTING PAVEMENT TO A STRAIGHT LINE AS REQUIRED TO REMOVE ANY BROKEN OR CRACKED PAVEMENT AND MATCH NEW TO EXISTING.
- WHEN REMOVAL OF EXISTING CURB AND GUTTER OR SIDEWALK IS REQUIRED, REMOVE BACK TO NEAREST JOINT.
- ALL GAS VALVE BOXES, GAS MANHOLES, ELECTRICAL MANHOLES, AND TELEPHONE MANHOLES WILL BE ADJUSTED TO GRADE BY OTHERS.
- TWO WORKING DAYS PRIOR TO ANY EXCAVATION, CONTRACTOR MUST CONTACT LINE & CABLE LOCATING SERVICE, 765-1234, FOR LOCATION OF EXISTING UTILITIES.
- CONTRACTOR IS TO EXERCISE DUE CARE TO AVOID DISTURBING ANY EXISTING UNDERGROUND UTILITIES. IT SHALL BE HIS RESPONSIBILITY TO COORDINATE WITH THE UTILITY COMPANIES IN ORDER TO PREVENT ANY SERVICE DISRUPTION THAT MIGHT RESULT FROM PROJECT CONSTRUCTION. IT SHALL BE HIS RESPONSIBILITY TO PROTECT AND PRESERVE UTILITY EQUIPMENT AFFECTED BY PROJECT CONSTRUCTION.
- EXACT LOCATION OF DRIVEPADS AND WHEELCHAIR RAMPS WILL BE DETERMINED IN THE FIELD BY THE FIELD ENGINEER. LOCATIONS SHOWN ON PLANS AND PROFILE SHEETS ARE APPROXIMATE.
- THE APPLICABLE CITY OF ALBUQUERQUE STANDARD DETAILS ARE INCLUDED AT THE BACK OF THE SPECIFICATIONS.
- ALL WATER VALVE BOXES AND SEWER MANHOLES IN THE CONSTRUCTION AREA ARE TO BE ADJUSTED TO FINISH GRADE UNDER THIS CONTRACT, AND WILL BE PAID FOR AT CONTRACT UNIT PRICES.
- SUBGRADE PREPARATION UNDER CURB AND GUTTER, DRIVEPADS AND SIDEWALK SHALL BE CONSIDERED INCIDENTAL TO THE CONSTRUCTION OF SUCH AND SHALL BE INCLUDED IN THE BID PRICE FOR SUCH ITEMS.
- A DISPOSAL SITE, COMPLYING WITH ALL CITY ORDINANCES, SHALL BE OBTAINED BY THE CONTRACTOR FOR THE DISPOSAL OF ALL EXCESS EXCAVATION MATERIAL, ASPHALTIC PAVEMENT (EXCEPT MILLED BITUMINOUS CONCRETE PAVEMENT) AND OTHER WASTE MATERIALS. THE CONTRACTOR SHALL NOTIFY THE CITY OF ALBUQUERQUE OF THE LOCATION OF THE DISPOSAL SITE PRIOR TO THE REMOVAL AND ACTUAL DISPOSAL OF THE MATERIAL. ALL COSTS IN OBTAINING A DISPOSAL SITE AND HAUL THERE TO SHALL BE CONSIDERED INCIDENTAL TO CONSTRUCTION AND NO DIRECT PAYMENT WILL BE MADE THEREFOR.
- THE CONTRACTOR WILL BE REQUIRED TO CONFINE HIS WORK WITHIN THE CONSTRUCTION LIMITS AND/OR R.O.W. TO PRESERVE EXISTING VEGETATION AND PRIVATE PROPERTY. OVERNIGHT PARKING OF CONSTRUCTION EQUIPMENT SHALL NOT OBSTRUCT DRIVEWAY OPENINGS OR DESIGNATED TRAFFIC LANES.
- FIFTY (50) TON ROLLER OPERATION SHALL NOT BE USED IN THIS PROJECT WHERE UNDERGROUND UTILITIES ARE PRESENT. THE REQUIRED COMPACTION AT THESE LOCATIONS SHALL BE EFFECTED BY OTHER MEANS.
- ALL EXCAVATIONS FOR STORM DRAINS, AND OTHER EXCAVATIONS AS NECESSARY, SHALL BE GOVERNED BY THE CONSTRUCTION SAFETY AND HEALTH STANDARDS (TITLE 29, CFR, PART 1926 AND PART 1910 AS APPLICABLE TO CONSTRUCTION WORK - PUBLISHED IN THE FEDERAL REGISTER ON FEBRUARY 9, 1979).
- THE CONTRACTOR SHALL NOTIFY THE ALBUQUERQUE TRAFFIC ENGINEERING DIVISION 3 WORKING DAYS IN ADVANCE OF ANY WORK REQUIRED REGARDING ALL EXISTING REGULATORY SIGNS AND SIGNALS THAT NEED TO BE REMOVED, RELOCATED OR REINSTALLED. CALL 764-1599
- WHERE PULL BOXES ABUT BACK OF CURB OR ARE LOCATED IN CONCRETE PAVED AREA PROVIDE 1/2" EXPANSION MATERIAL. ALL PULL BOXES TO BE FLUSH WITH SURFACE OF CONCRETE.
- CONTRACTOR WILL BE RESPONSIBLE FOR CONNECTING NEW CONDUIT TO EXISTING OR NEW TRAFFIC CONTROL FACILITIES. THIS WORK WILL BE CONSIDERED INCIDENTAL TO CONSTRUCTION AND NO SEPARATE PAYMENT WILL BE MADE THEREFOR.
- PERMANENT SIGNING AND ALL STRIPING SHALL BE BY CITY FORCES. CONSTRUCTION SIGNING AND STRIPING SHALL BE BY CONTRACTOR.
- DELETED
- EXISTING MEDIAN CURB AND GUTTER AND STANDARD CURB AND GUTTER, NOT DISTURBED BY THE CONTRACTOR, AND THAT IS OUT OF ALIGNMENT OR DISPLACED VERTICALLY OR IS BADLY BROKEN OR DETERIORATED WILL BE REPLACED AS DIRECTED BY THE FIELD ENGINEER, AND WILL BE PAID FOR AT CONTRACT UNIT PRICES.
- THE CONTRACTOR SHALL NOTIFY WATER SYSTEMS DIVISION AT LEAST 2 WORKING DAYS IN ADVANCE OF WHEN FIRE HYDRANTS WILL BE TAKEN OUT OF SERVICE AND RETURNED TO SERVICE.
- ALL TRAFFIC CONTROL DEVICES SHALL COMPLY WITH THE CURRENT EDITION OF "MANUAL FOR UNIFORM TRAFFIC CONTROL DEVICES."
- ALL TRAFFIC CONTROL SIGNS MUST BE INSTALLED BEFORE CONSTRUCTION BEGINS FOR EACH PHASE OF THE WORK AS DIRECTED BY THE FIELD ENGINEER. ALL SIGN LOCATIONS WILL BE SELECTED IN THE FIELD AND APPROVED BY THE FIELD ENGINEER. SIGN HEIGHT SHALL BE 7 FT. ABOVE THE SIDEWALK LEVEL TO THE BOTTOM OF SIGN.
- ALL DRUMS USED FOR TRAFFIC CONTROL MAY BE FILLED WITH SAND OR WATER BALLAST LIMITED TO 100 LBS. MAXIMUM PER DRUM.
- THE CONTRACTOR SHALL PROVIDE AND MAINTAIN A SAFE AND ADEQUATE MEANS OF CHANNELING PEDESTRIAN TRAFFIC AROUND ALL WORK AREAS THROUGHOUT THE CONSTRUCTION PERIOD.
- DELETED
- THE CONTRACTOR SHALL MAINTAIN CONTINUOUS ACCESS TO ALL PROPERTY EXCEPT DURING ACTUAL PAVING OPERATIONS. PRIOR TO ANY PAVING OPERATIONS THE CONTRACTOR SHALL NOTIFY THE PROPERTY OWNERS 3 DAYS IN ADVANCE.
- THE CONCRETE PAVEMENT FOR WHEELCHAIR RAMPS IS INCLUDED IN THE BID ITEM, "4 INCH CONCRETE SIDEWALK INCLUDING 6 INCH SUBGRADE PREPARATION."
- ALL ADVANCE WARNING SIGNS AND ALL BARRICADES SHALL BE EQUIPPED WITH FLASHING WARNING LIGHTS, TYPE A, EXCEPT ALL CHANNELIZING BARRICADES SHALL HAVE STEADY BURNING WARNING LIGHTS, TYPE C.
- WHEELCHAIR RAMPS SHALL BE CONSTRUCTED AT ALL CURB RETURNS CONSTRUCTED ON THIS PROJECT AT LOCATION SHOWN ON THE PLANS, IN ACCORDANCE WITH CITY STANDARD DETAILS. WHEELCHAIR RAMPS SHALL BE MEASURED AND PAID AS CONCRETE SIDEWALK AND CONCRETE CURB AND GUTTER.
- ALL WATER LINES CONSTRUCTED AS A PART OF THIS PROJECT SHALL HAVE A MINIMUM OF 48" COVER FROM FINISHED GRADE TO TOP OF PIPE.
- TEMPORARY RELOCATION OF MAILBOXES MAY BE REQUIRED DURING CONSTRUCTION. THIS WORK SHALL BE CONSIDERED INCIDENTAL TO COMPLETION OF THE WORK AND NO PAYMENT WILL BE MADE THEREFOR. ALL NECESSARY MAIL BOX RELOCATIONS SHALL BE COORDINATED WITH THE U.S. POSTAL SERVICE PRIOR TO MOVING AND ALL NEW LOCATIONS SHALL BE APPROVED BY THEM.

- ALL MAILBOXES THAT ARE RELOCATED WILL BE REINSTALLED AS DIRECTED. THE INSTALLATION SHALL BE PERMANENT IN NATURE.
- CONCRETE BLOCKING WILL BE INSTALLED AS REQUIRED AND IN ACCORDANCE WITH CITY OF ALBUQUERQUE STANDARD DRAWINGS OR AS DIRECTED BY THE ENGINEER.
- MANHOLE RIM ELEVATIONS SHOWN ON THESE PLANS ARE APPROXIMATE AND WILL VARY IN ACCORDANCE WITH FINISHED PAVEMENT ELEVATIONS.
- CONTRACTOR SHALL FIELD VERIFY LOCATION AND TYPE OF EXISTING UTILITIES TO BE ADJUSTED OR EXTENDED.
- MILLED BITUMINOUS CONCRETE PAVEMENT WILL BE STOCKPILED FOR THE CITY AS DIRECTED BY ENGINEER.
- EXISTING ENTRANCE PIPE AND CULVERTS TO BE REMOVED SHALL BE THE PROPERTY OF THE CONTRACTOR AND SHALL BE DISPOSED OF BY THE CONTRACTOR.
- CONTRACTOR TO VERIFY ALL FLANGE, PAD, VALVE BOX, RIM AND TOP OF PIPE ELEVATIONS IN FIELD. ELEVATIONS SHALL BE ADJUSTED TO COMPLY WITH REQUIREMENTS OF STANDARD CITY DETAILS.
- The contractor will be responsible for coordinating the execution of the water valve shut-off plan with the Water Systems Division (823-4200) 3 working days in advance of any work that may affect existing Public Water Utilities.
- The contractor shall coordinate with U.S. West on relocation of any telephone boxes.

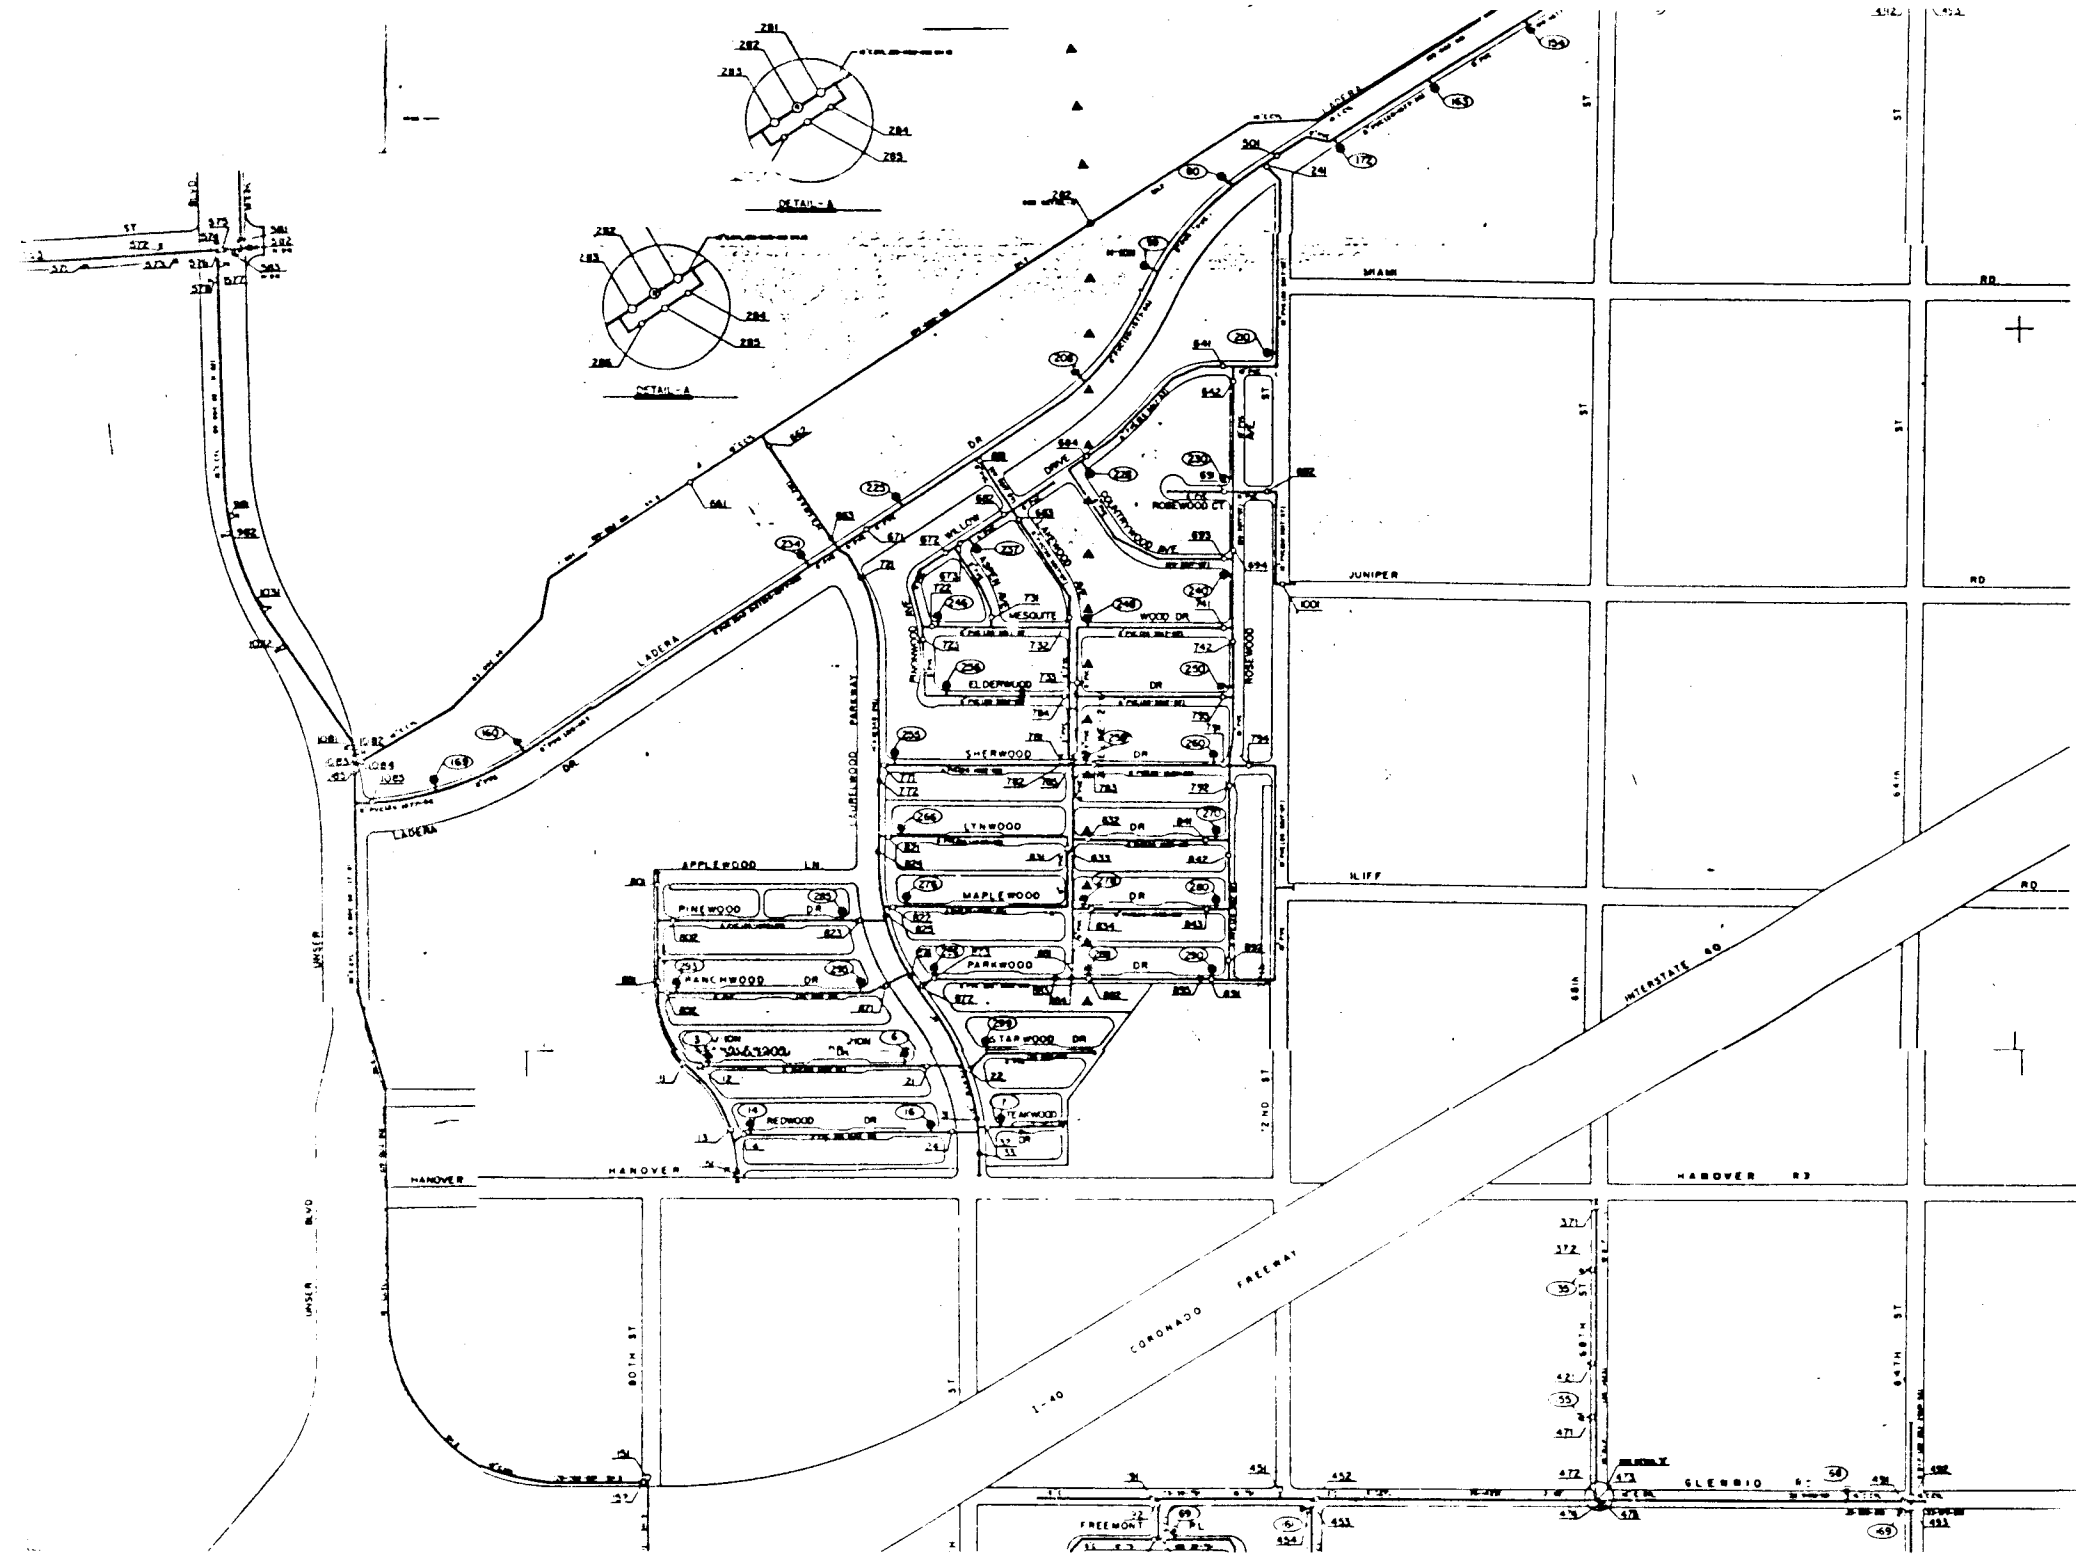

WATER VALVE SHUTOFF PLAN (SEE SHEET 52)

- 72ND ST. & ILIFF SHALL BE COMPLETED PRIOR TO AUGUST 15, 1989 TO PROVIDE ACCESS TO THE APS SCHOOL SITE.

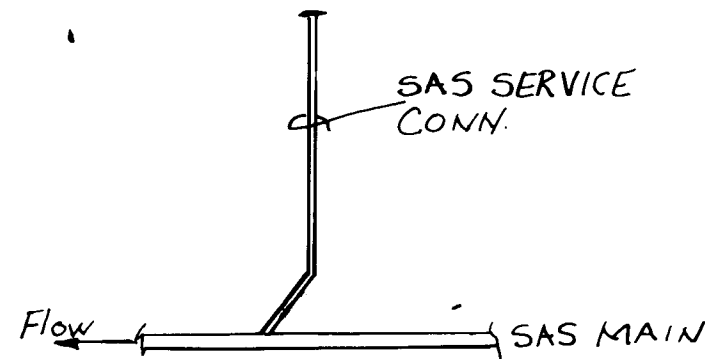

SAS SERVICE CONNECTION DETAIL
All SAS Service Connections shall be Directional Tee's or Wye's.

LEGEND

EXISTING UTILITIES

- G GAS
- W WATER
- 645 SANITARY SEWER
- 50 STORM DRAIN
- M MANHOLE
- V VALVE
- UTILITY POLE
- L LIGHT POLE
- F FIRE HYDRANT
- CB CATCH BASIN
- T5 TRAFFIC SIGNAL
- BT BURIED TEL. CABLE
- PB PULL BOX
- SP SIGN POST
- TCB TRAFFIC CONTROL BOX
- WM WATER METER
- UE UNDERGROUND ELEC. CABLE
- CATV UNDERGROUND CABLE T.V.

NOTE: EXISTING FACILITIES ARE DASHED

PLAN

- CONCRETE DRIVEPAD TO BE CONSTRUCTED
- VALLEY GUTTER TO BE CONSTRUCTED
- CONCRETE SIDEWALK TO BE CONSTRUCTED
- PAVEMENT TO BE REMOVED
- CONCRETE MEDIAN PAVEMENT TO BE CONSTRUCTED
- PAVEMENT GRADE
- PAVEMENT CURB
- SIDEWALK NOT TO BE CONSTRUCTED THIS CONTRACT
- N.I.C. - NOT IN CONTRACT

1 2 3 4 5 6 7 8 9 10 11 12
26 32 29 02 910

CITY OF ALBUQUERQUE
PUBLIC WORKS DEPARTMENT
SPECIAL ASSESSMENT DISTRICT NO. 218

GENERAL NOTES


Drawn by	Engineer	Check	Date	Scale
R. H. HANLEY	R. H. HANLEY	R. H. HANLEY	3-14-89	AS SHOWN
3-14-89	3-14-89	3-14-89	3-14-89	3-14-89
3-14-89	3-14-89	3-14-89	3-14-89	3-14-89
3-14-89	3-14-89	3-14-89	3-14-89	3-14-89
3-14-89	3-14-89	3-14-89	3-14-89	3-14-89
3-14-89	3-14-89	3-14-89	3-14-89	3-14-89
3-14-89	3-14-89	3-14-89	3-14-89	3-14-89
3-14-89	3-14-89	3-14-89	3-14-89	3-14-89
3-14-89	3-14-89	3-14-89	3-14-89	3-14-89

DRAWING NO. 3229 MAP NO. SHEET 2 OF 52


RECORD DRAWING
DATE 3-1-90

GARDNER, MASON & ASSOCIATES, INC.
ENGINEERS & PLANNERS
ALBUQUERQUE, N.M.


WILSON & COMPANY
ENGINEERS & ARCHITECTS
ALBUQUERQUE, N.M.

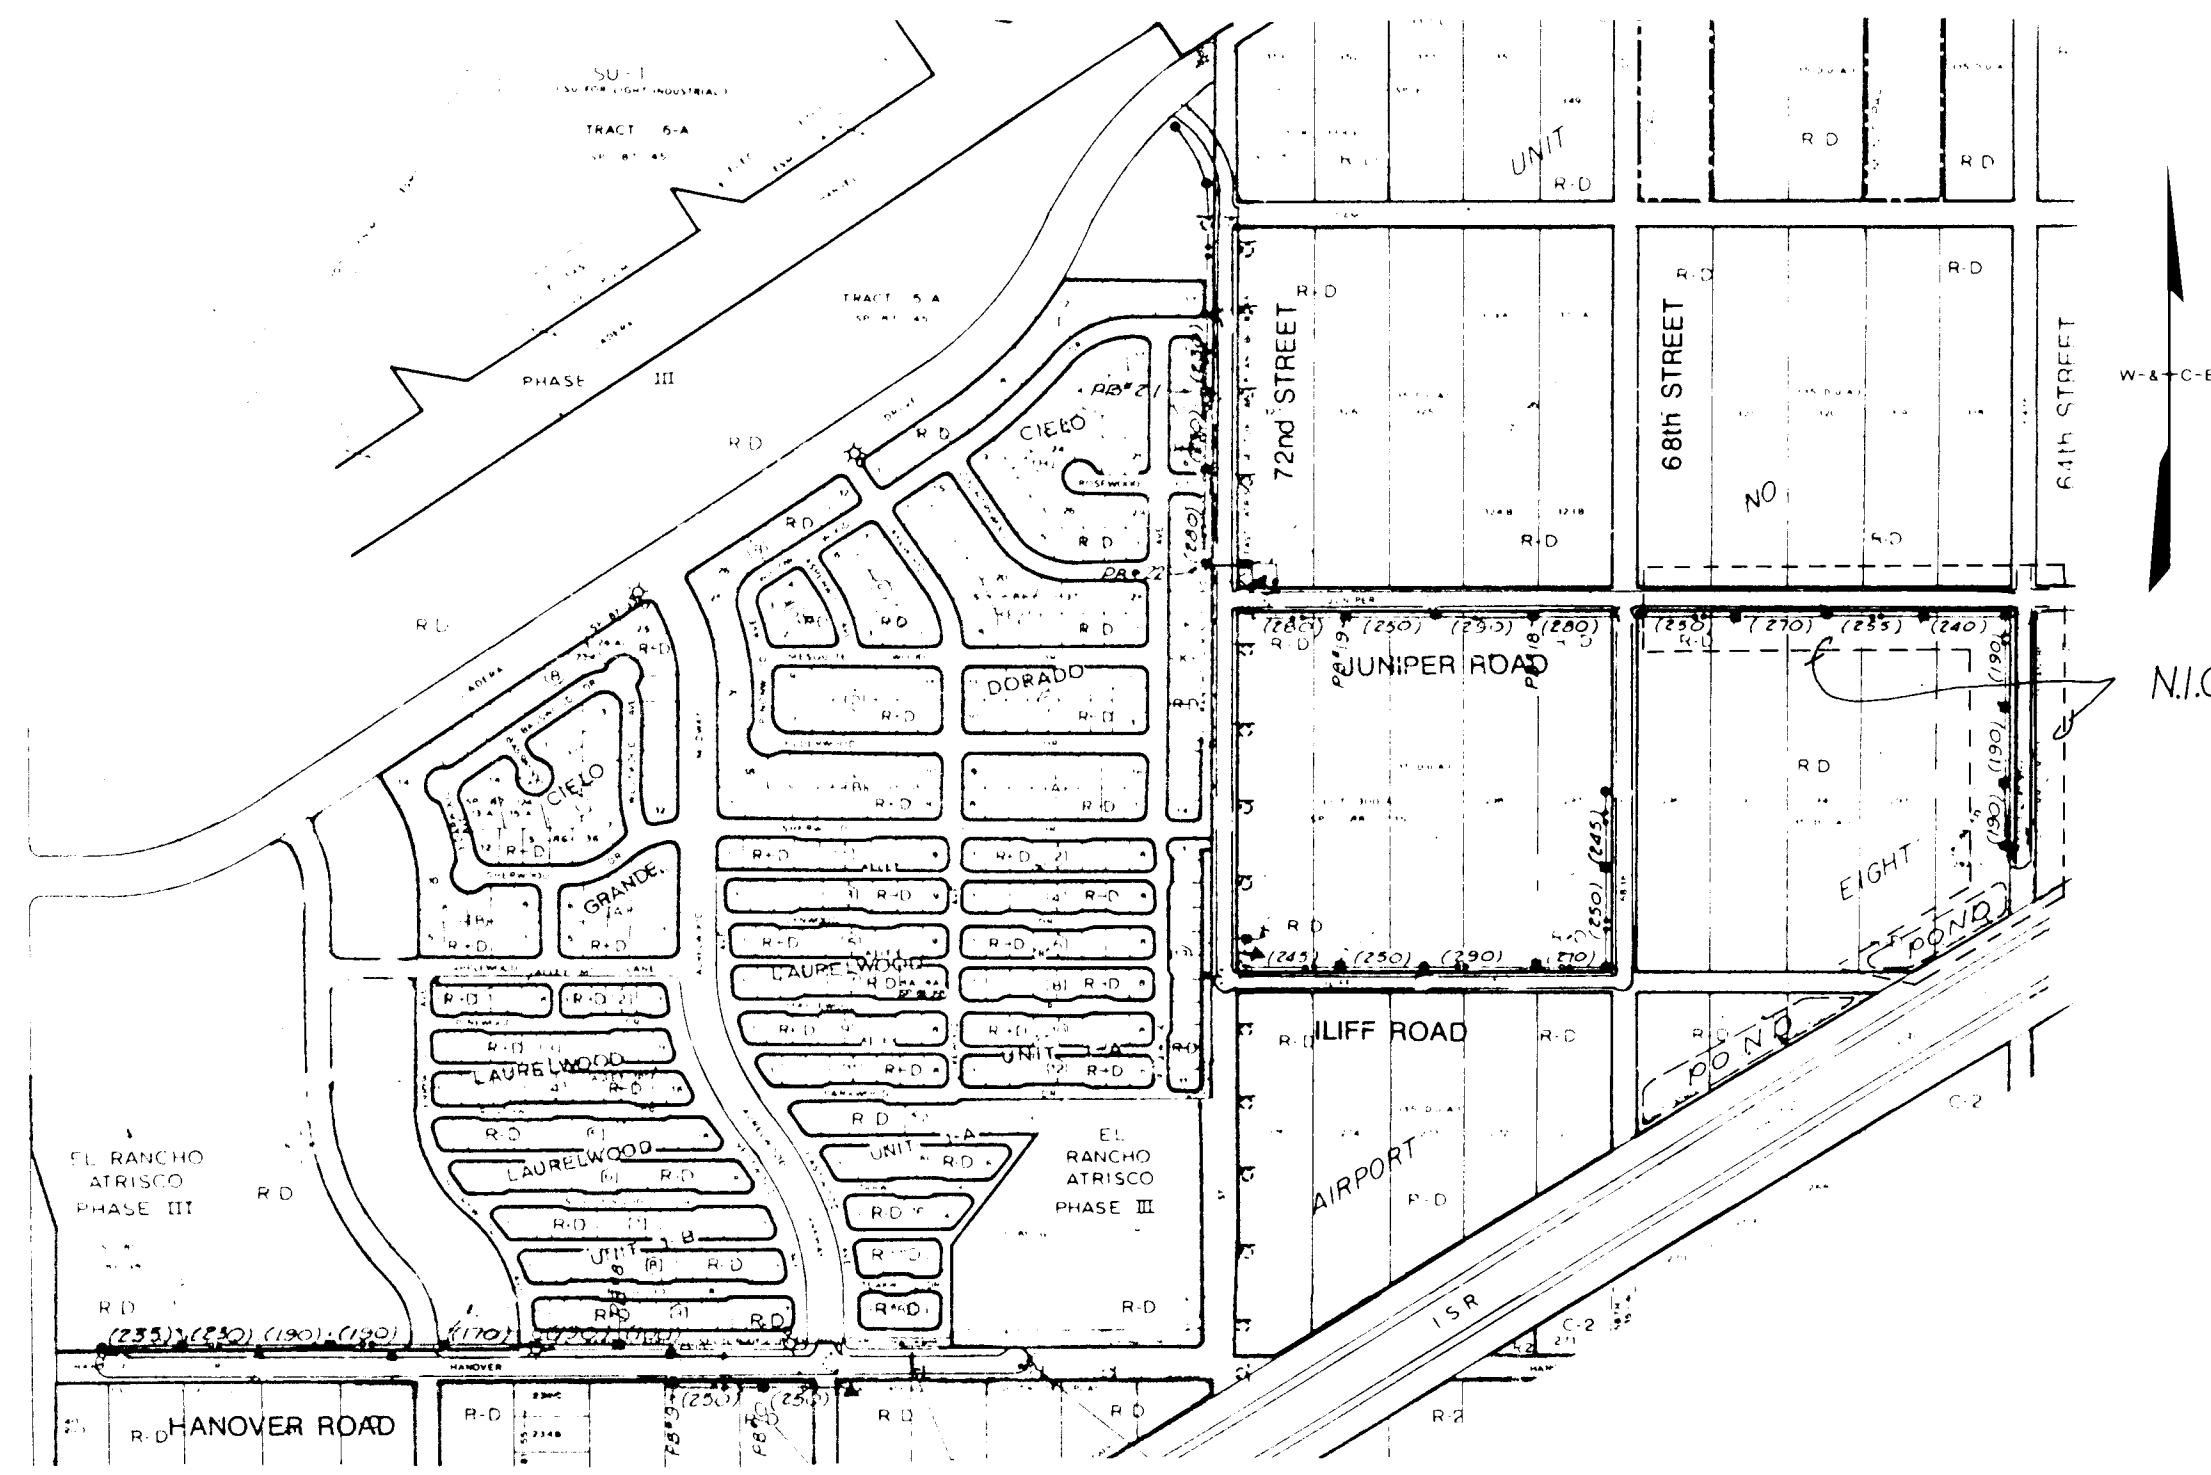


PAVEMENT LOCATION MAP

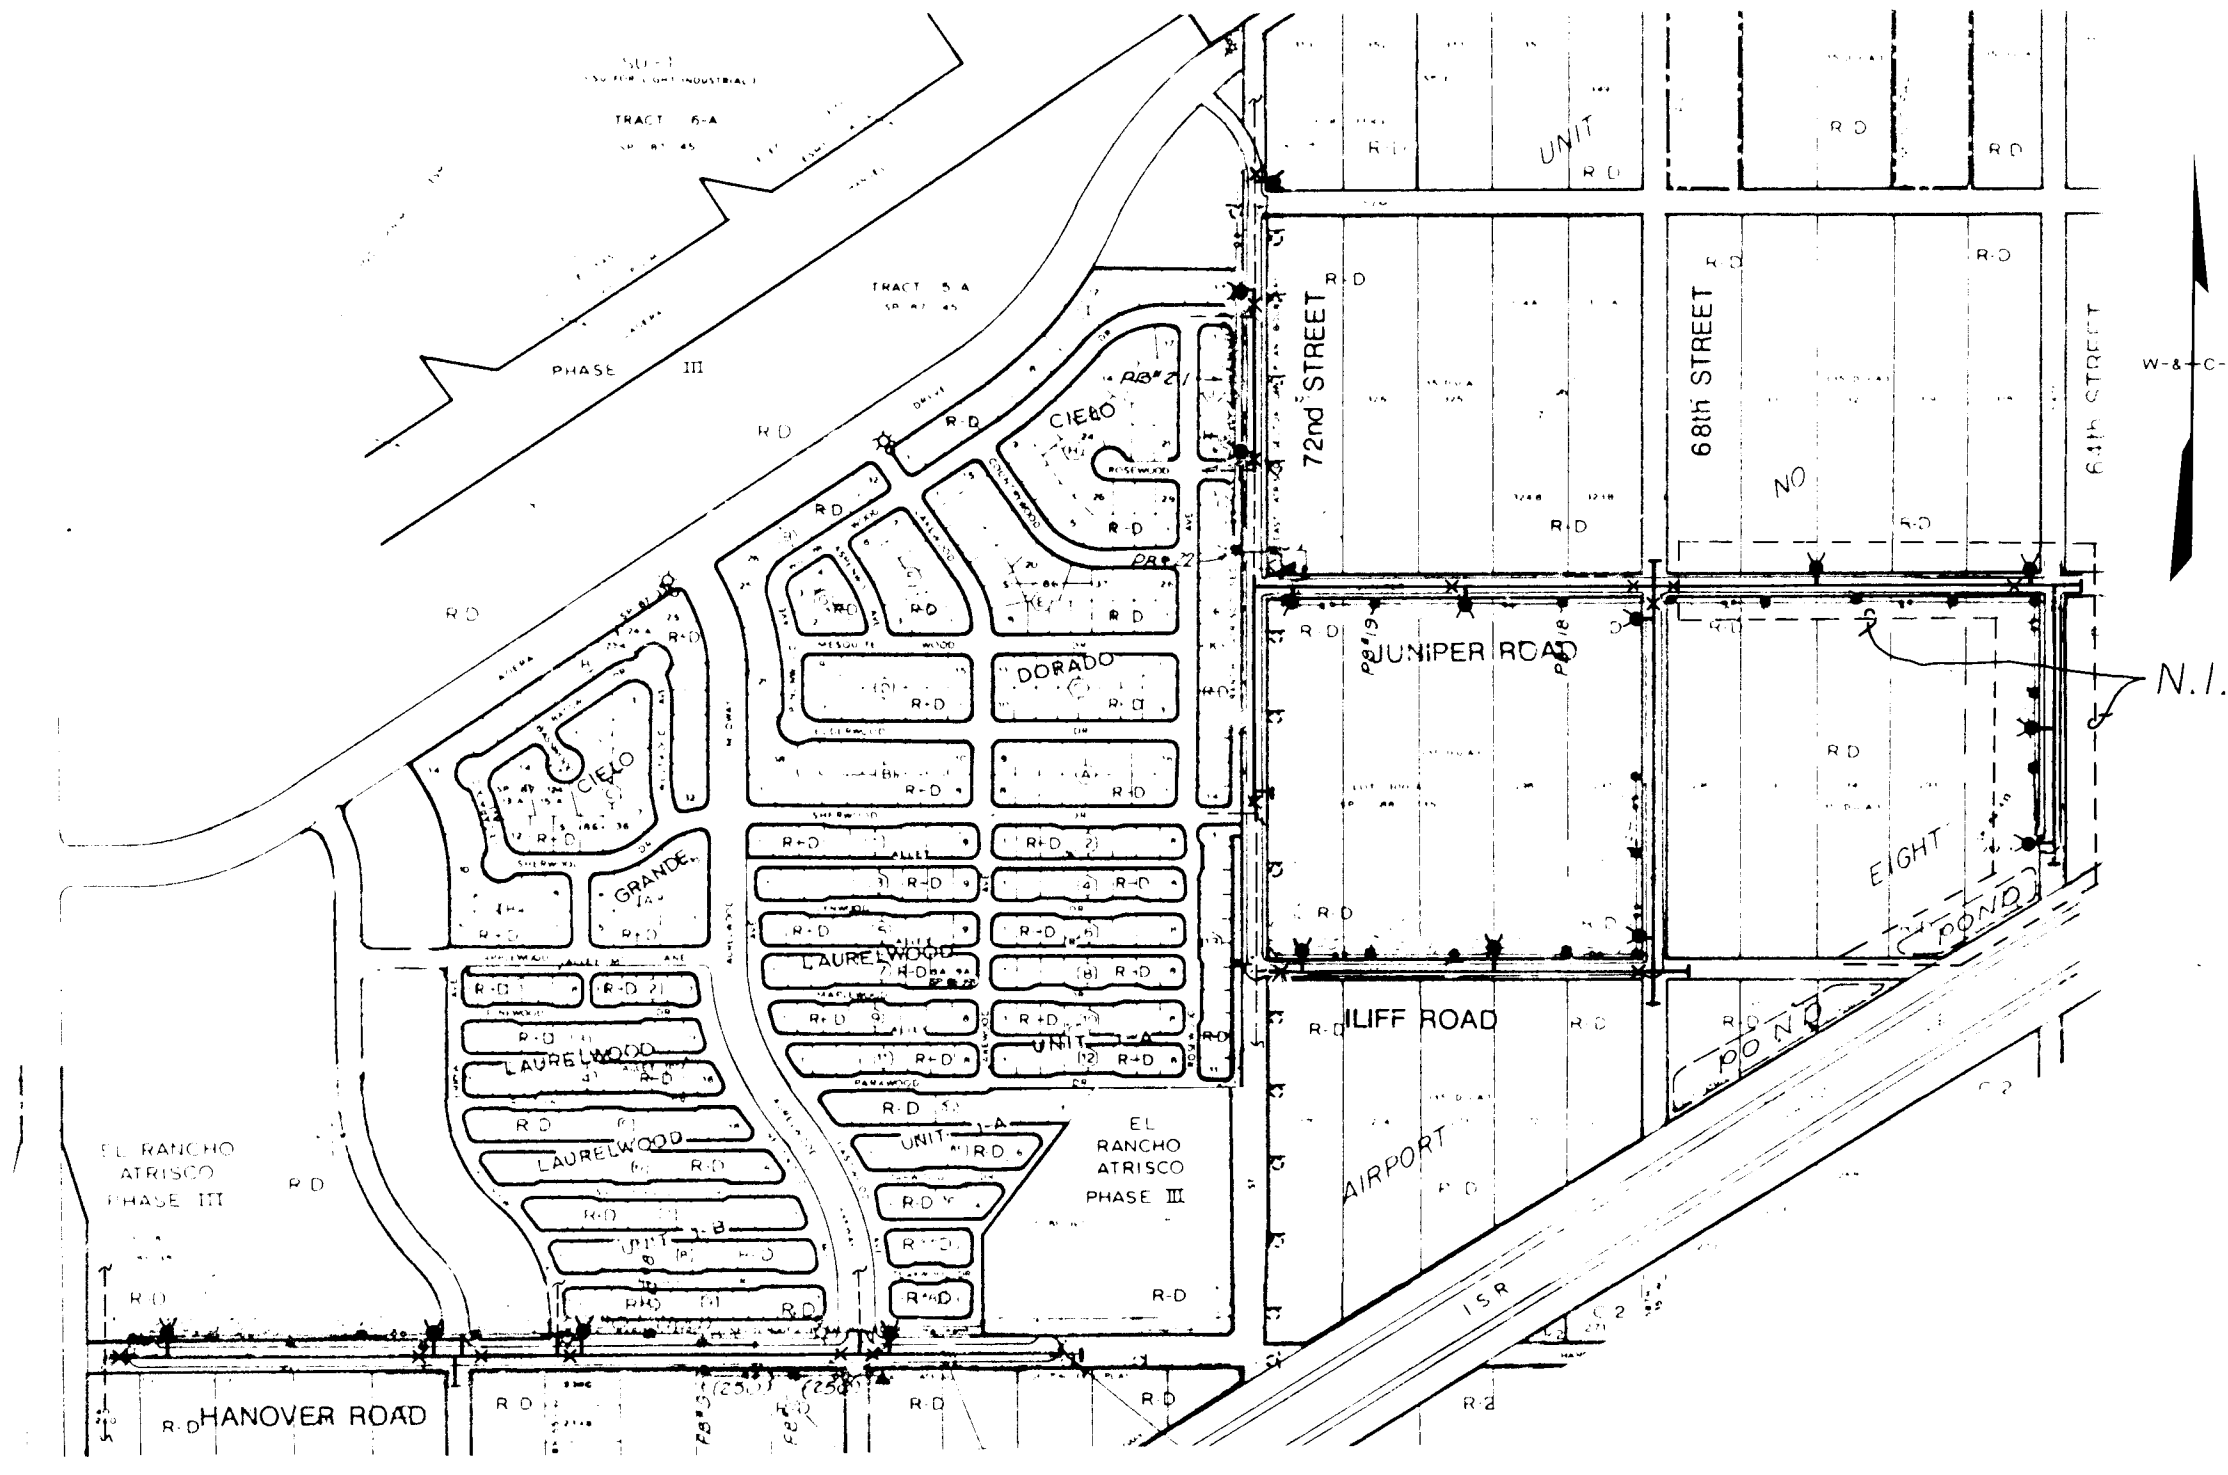

WATERLINE LOCATION MAP

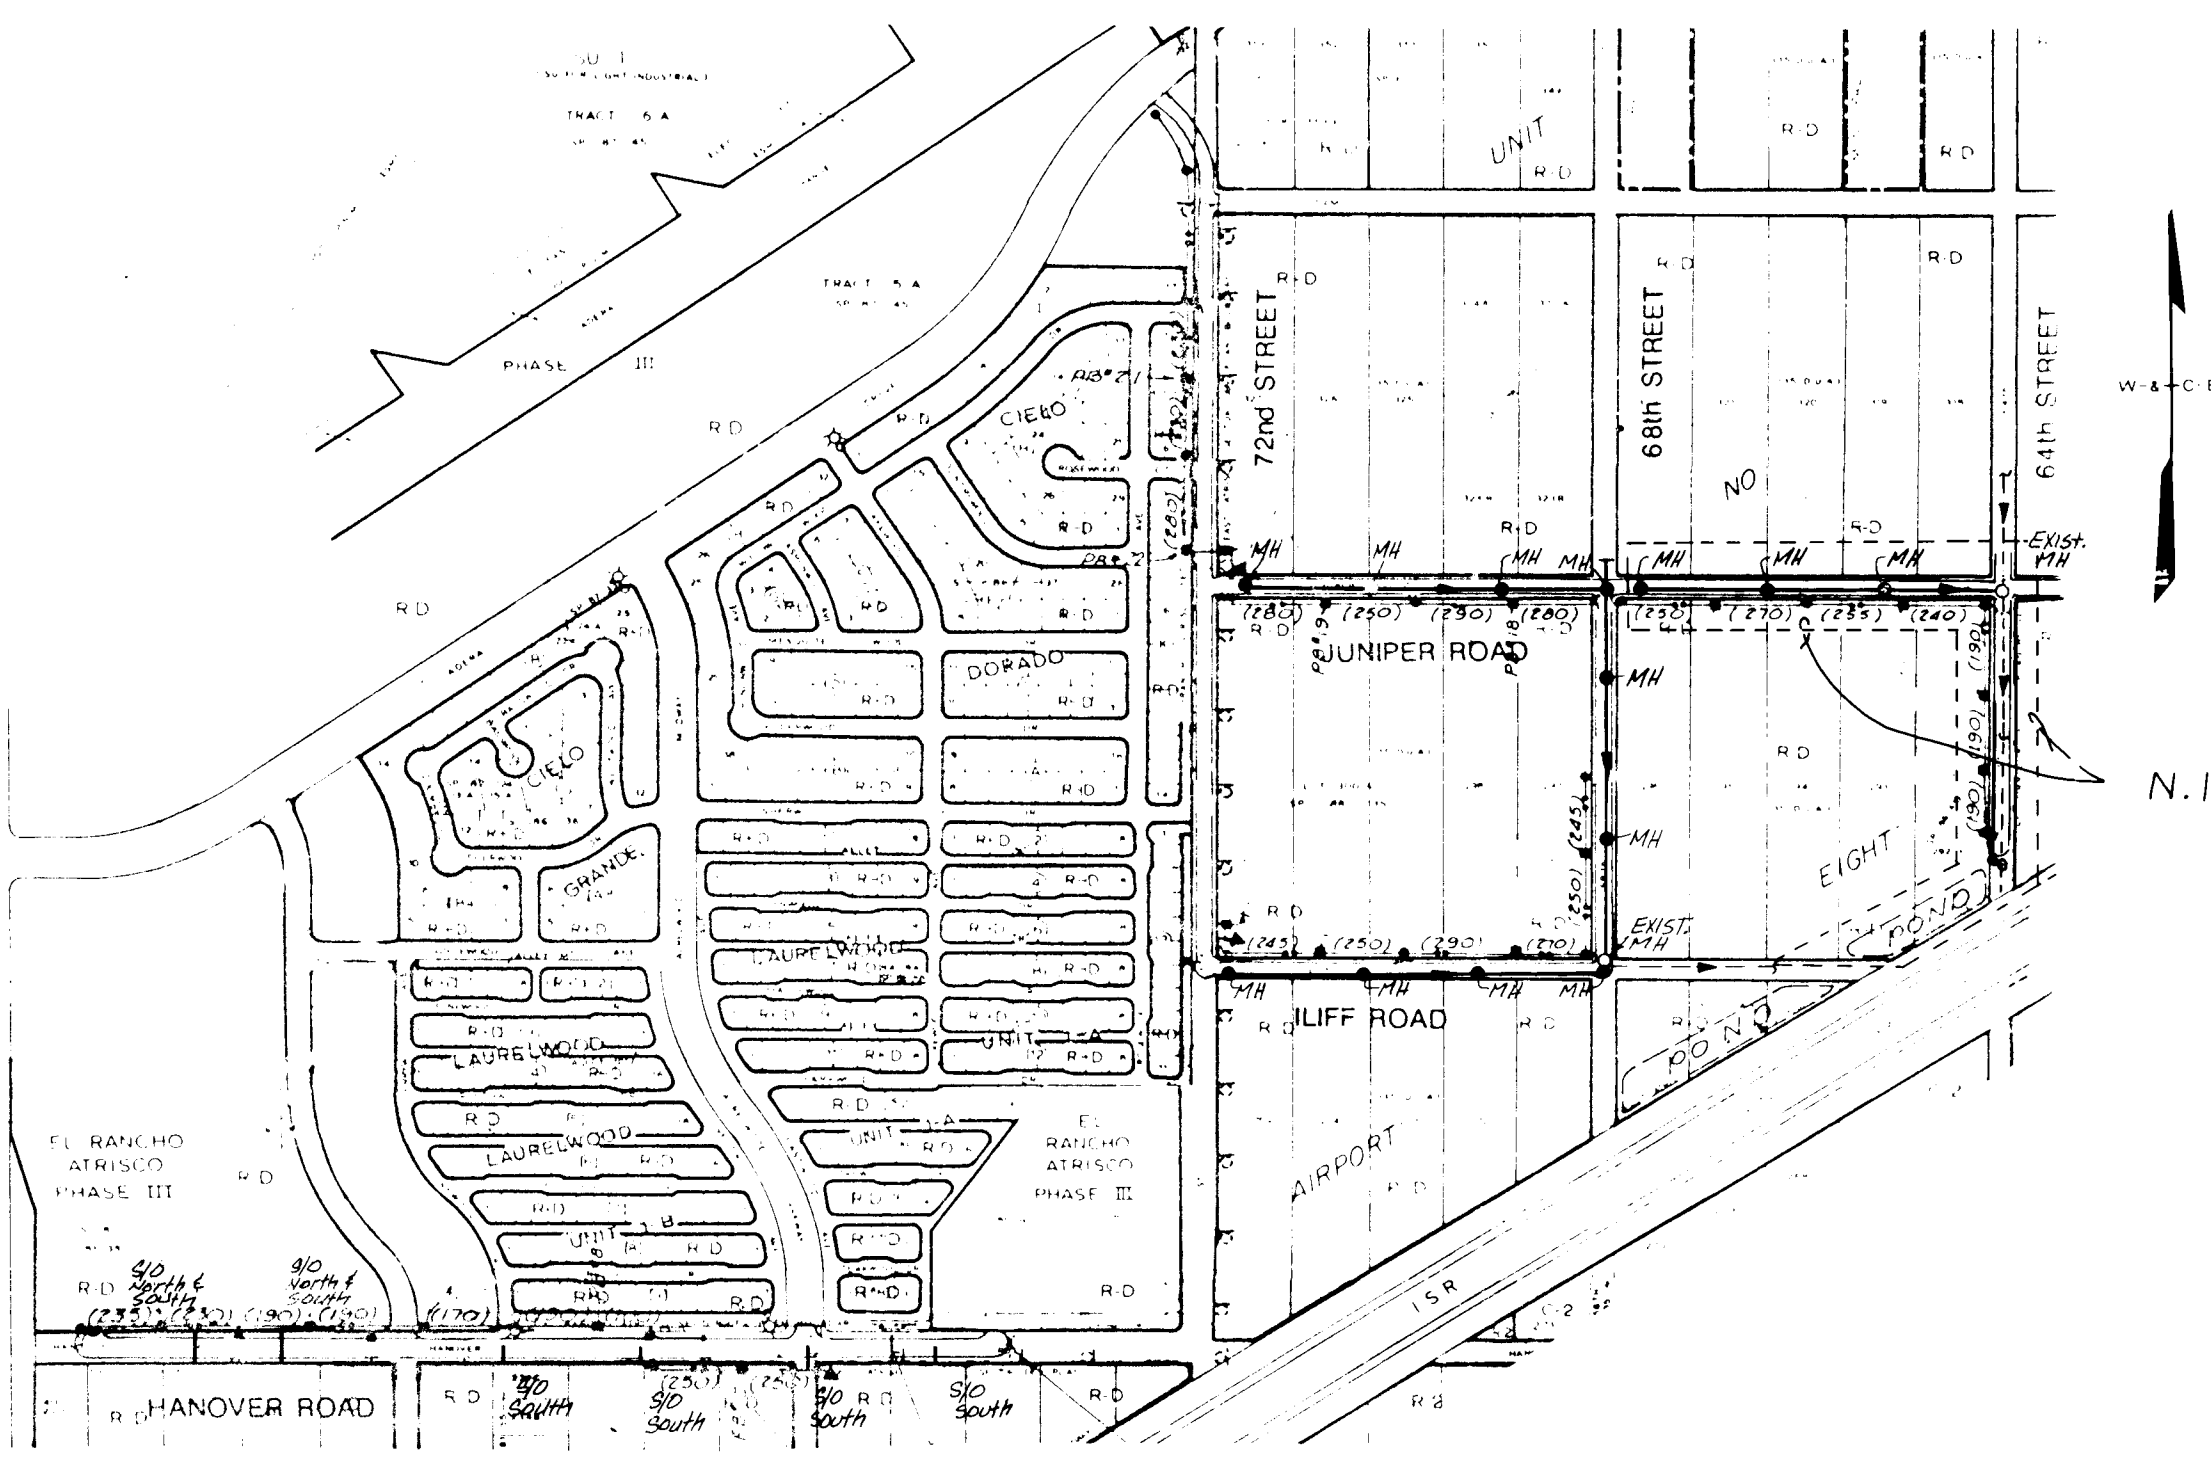

SANITARY SEWER LOCATION MAP

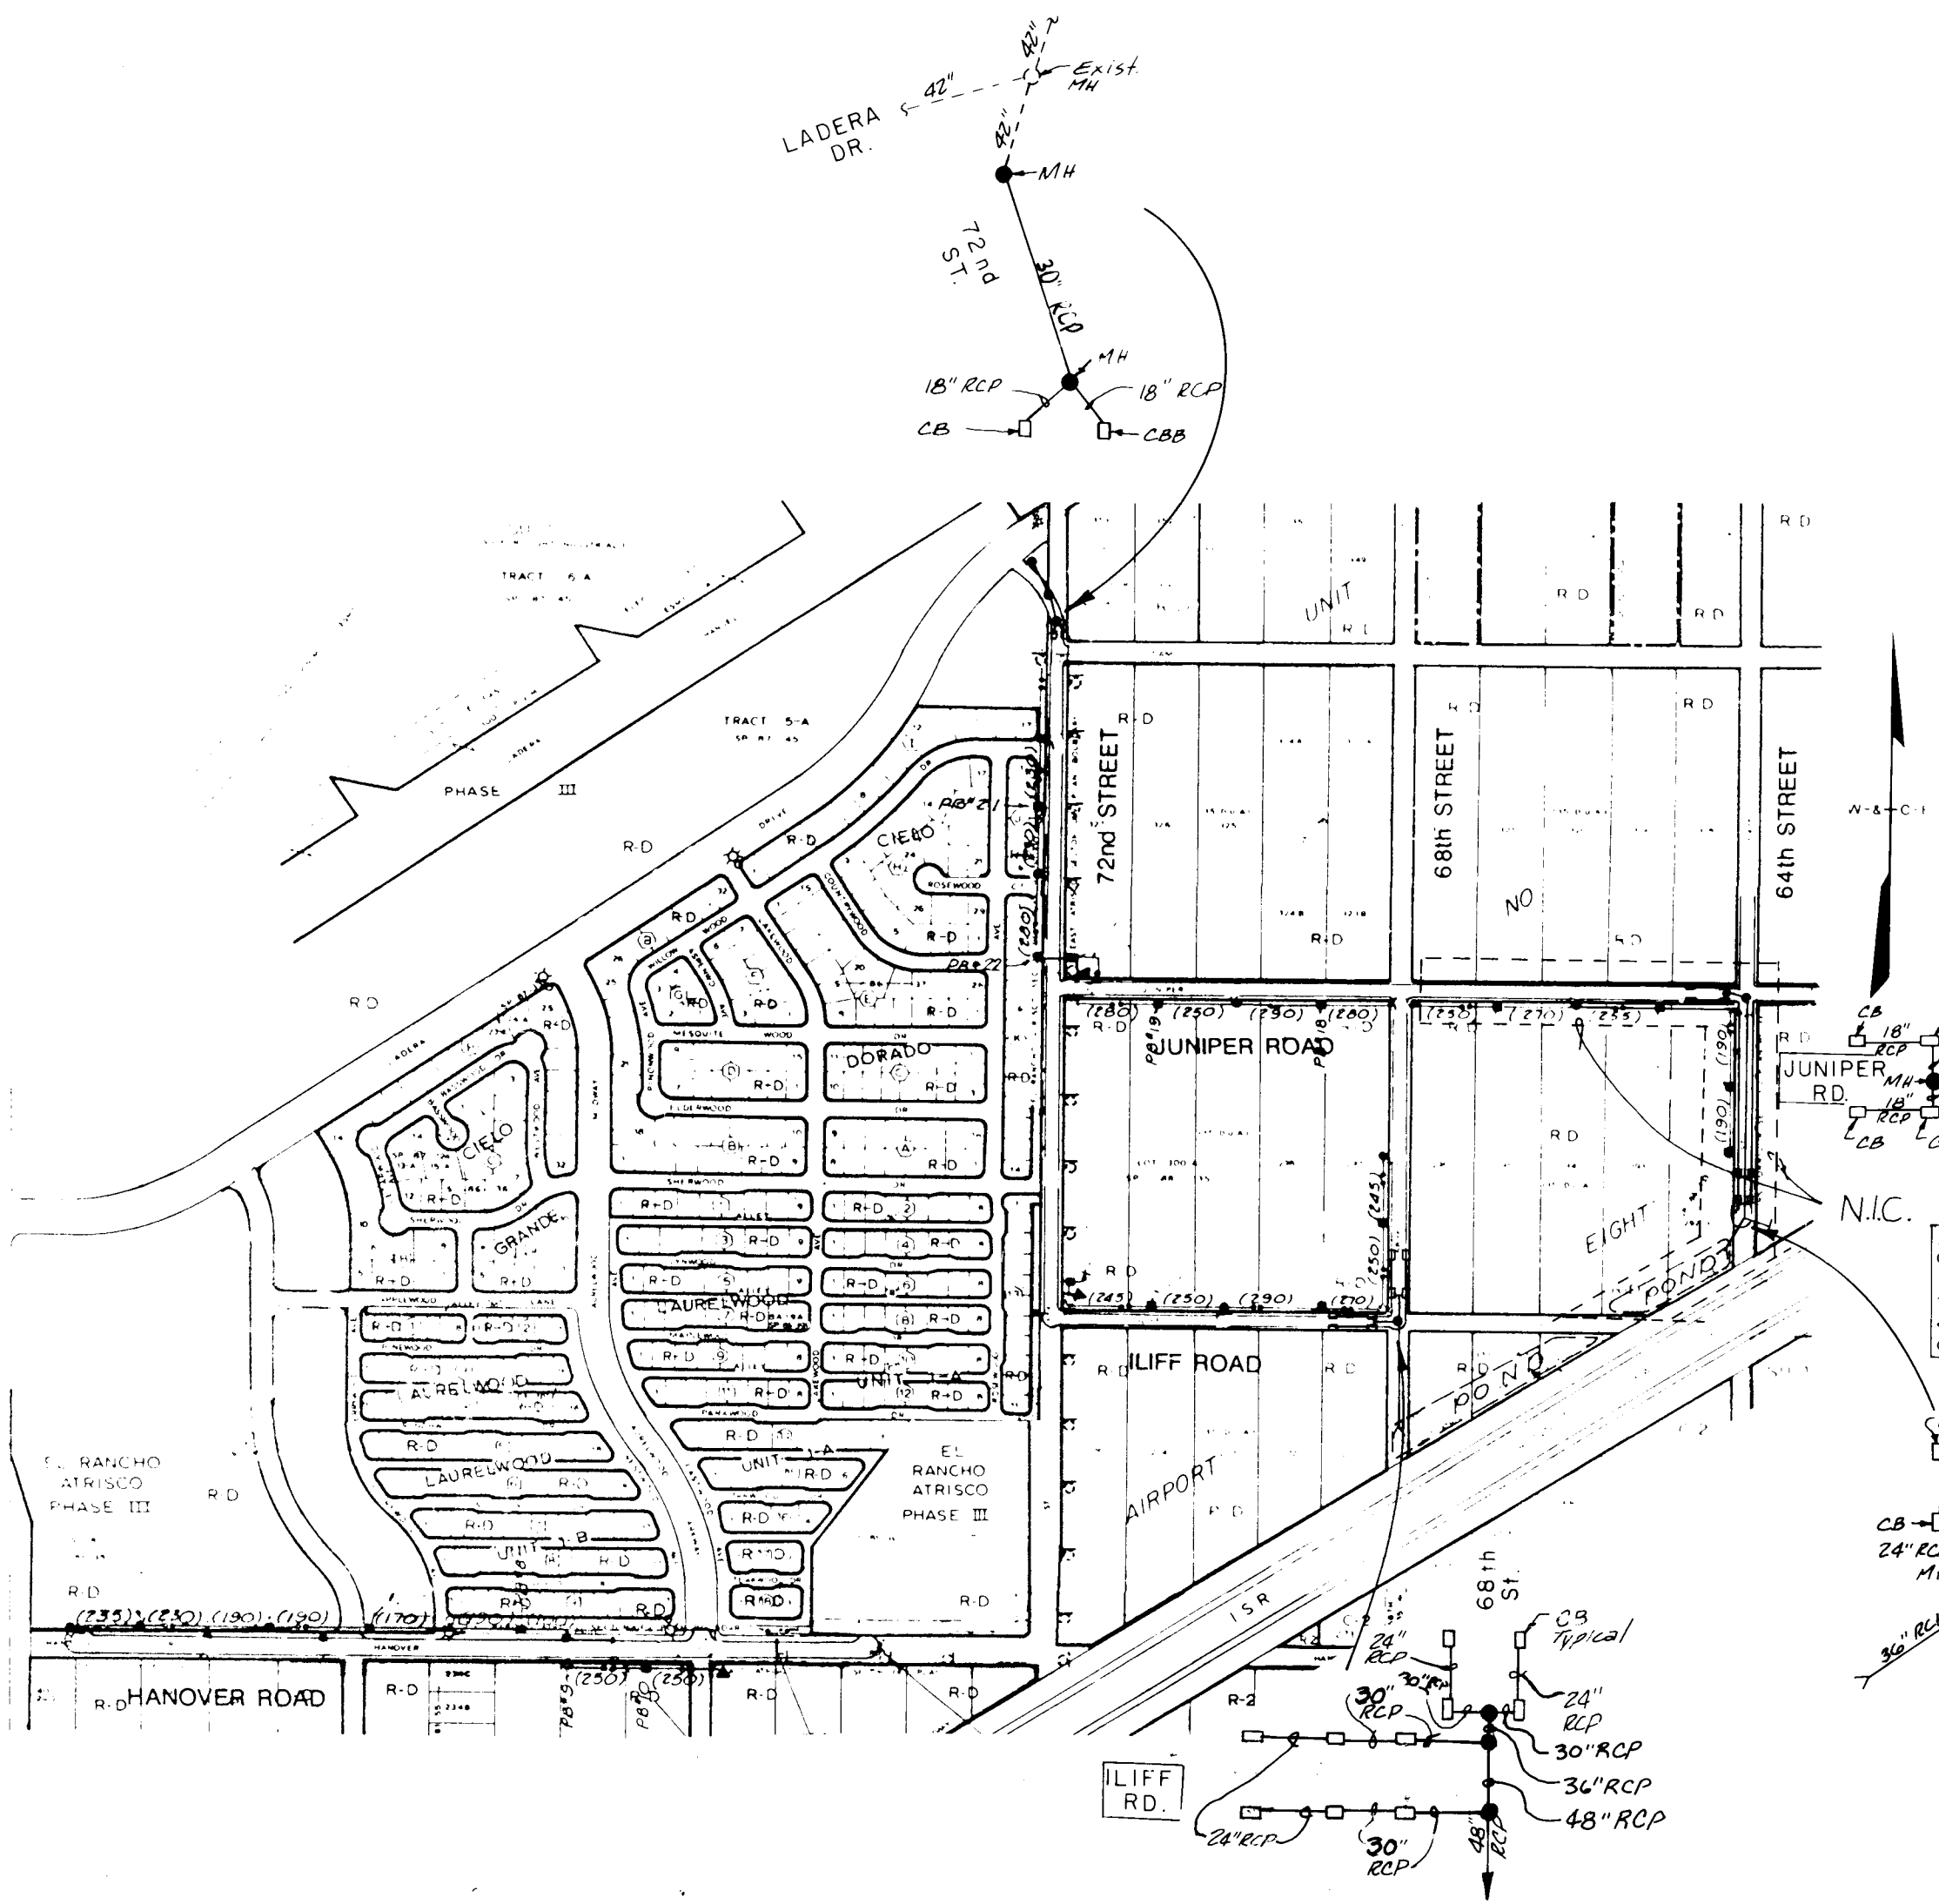

STORM SEWER LOCATION MAP

LASON 1-505-344-9404
BEST COPY AVAILABLE

NOTE
1. See sheet 51 of these plans
For Location Map G-13. Map
G-13 delineates Indian Farm
Lane. Sheet 51 will also show
Paving and Storm Drain Design
and Street Lighting Layout.

N.I.C. - Not In Contract

AS BUILT INFORMATION			BENCH MARKS			SURVEY INFORMATION			ENGINEER'S SEAL		
CONTRACTOR	UNIVERSAL CONSTRUCTION	DATE	NO.	BY	DATE	FIELD NOTES			REVISIONS		
WORK	DATE	DATE	NO.	BY	DATE	NO.			DATE		
STAKED BY	DATE	DATE	NO.	BY	DATE	NO.			DATE		
ACCEPTANCE BY	DATE	DATE	NO.	BY	DATE	NO.			DATE		
FIELD	DATE	DATE	NO.	BY	DATE	NO.			DATE		
DESIGNATION BY	DATE	DATE	NO.	BY	DATE	NO.			DATE		
CORRECTED BY	DATE	DATE	NO.	BY	DATE	NO.			DATE		
RECORDED BY	DATE	DATE	NO.	BY	DATE	NO.			DATE		

CITY OF ALBUQUERQUE PUBLIC WORKS DEPARTMENT SPECIAL ASSESSMENT DISTRICT NO. 218					
LOCATION MAPS					
APPROVALS	ENGINEER	DATE	APPROVALS	ENGINEER	DATE
City Engineer	Rogers	3-14-89	Liquid Waste	REDO	3/6/89
ACE - Design	"	"	Traffic	Rogers	3-14-89
ACE - Hydrology	AM	3-7-89	Water	Winters	3/6/89
DRAWING NO.	3229	MAP NO.	H-10 & J-10	SHEET	3 OF 52


RECORD DRAWING
DATE 3-1-90

WILSON & COMPANY
ENGINEERS & ARCHITECTS
ALBUQUERQUE, NEW MEXICO

CITY OF ALBUQUERQUE
ALBUQUERQUE, NEW MEXICO
RECEIVED
INTER-OFFICE CORRESPONDENCE January 4, 1988
JAN 4 1988
FILE NO. 3229
PHD/ENGINEERING GROUP
TO: Andre Moule, Chairman, Design Review Committee
FROM: Bill Coleman, Traffic Engineering Operations
SUBJECT: TRAFFIC CONTROL PLAN FOR STREET IMPROVEMENTS, SPECIAL ASSESSMENT DISTRICT NO. 218, PROJECT NO. 3229

Consulting Engineer shall incorporate the following typicals as the Traffic Control Plan.
Consulting Engineer shall incorporate the following notes as the general notes on the Traffic Control Plan.

- 1) Contractor shall adhere to Section 19 of the City of Albuquerque Standard Specifications for Construction, 1986.
- 2) Contractor shall limit the length of open excavation to no more than (200) feet. Contractor can not proceed with excavation until previous excavation is refilled, compacted, and temporarily asphalted.
- 5) Contractor shall adhere to Section SP-3 of the Public Works contract, pertaining to proper median publication of construction operations.

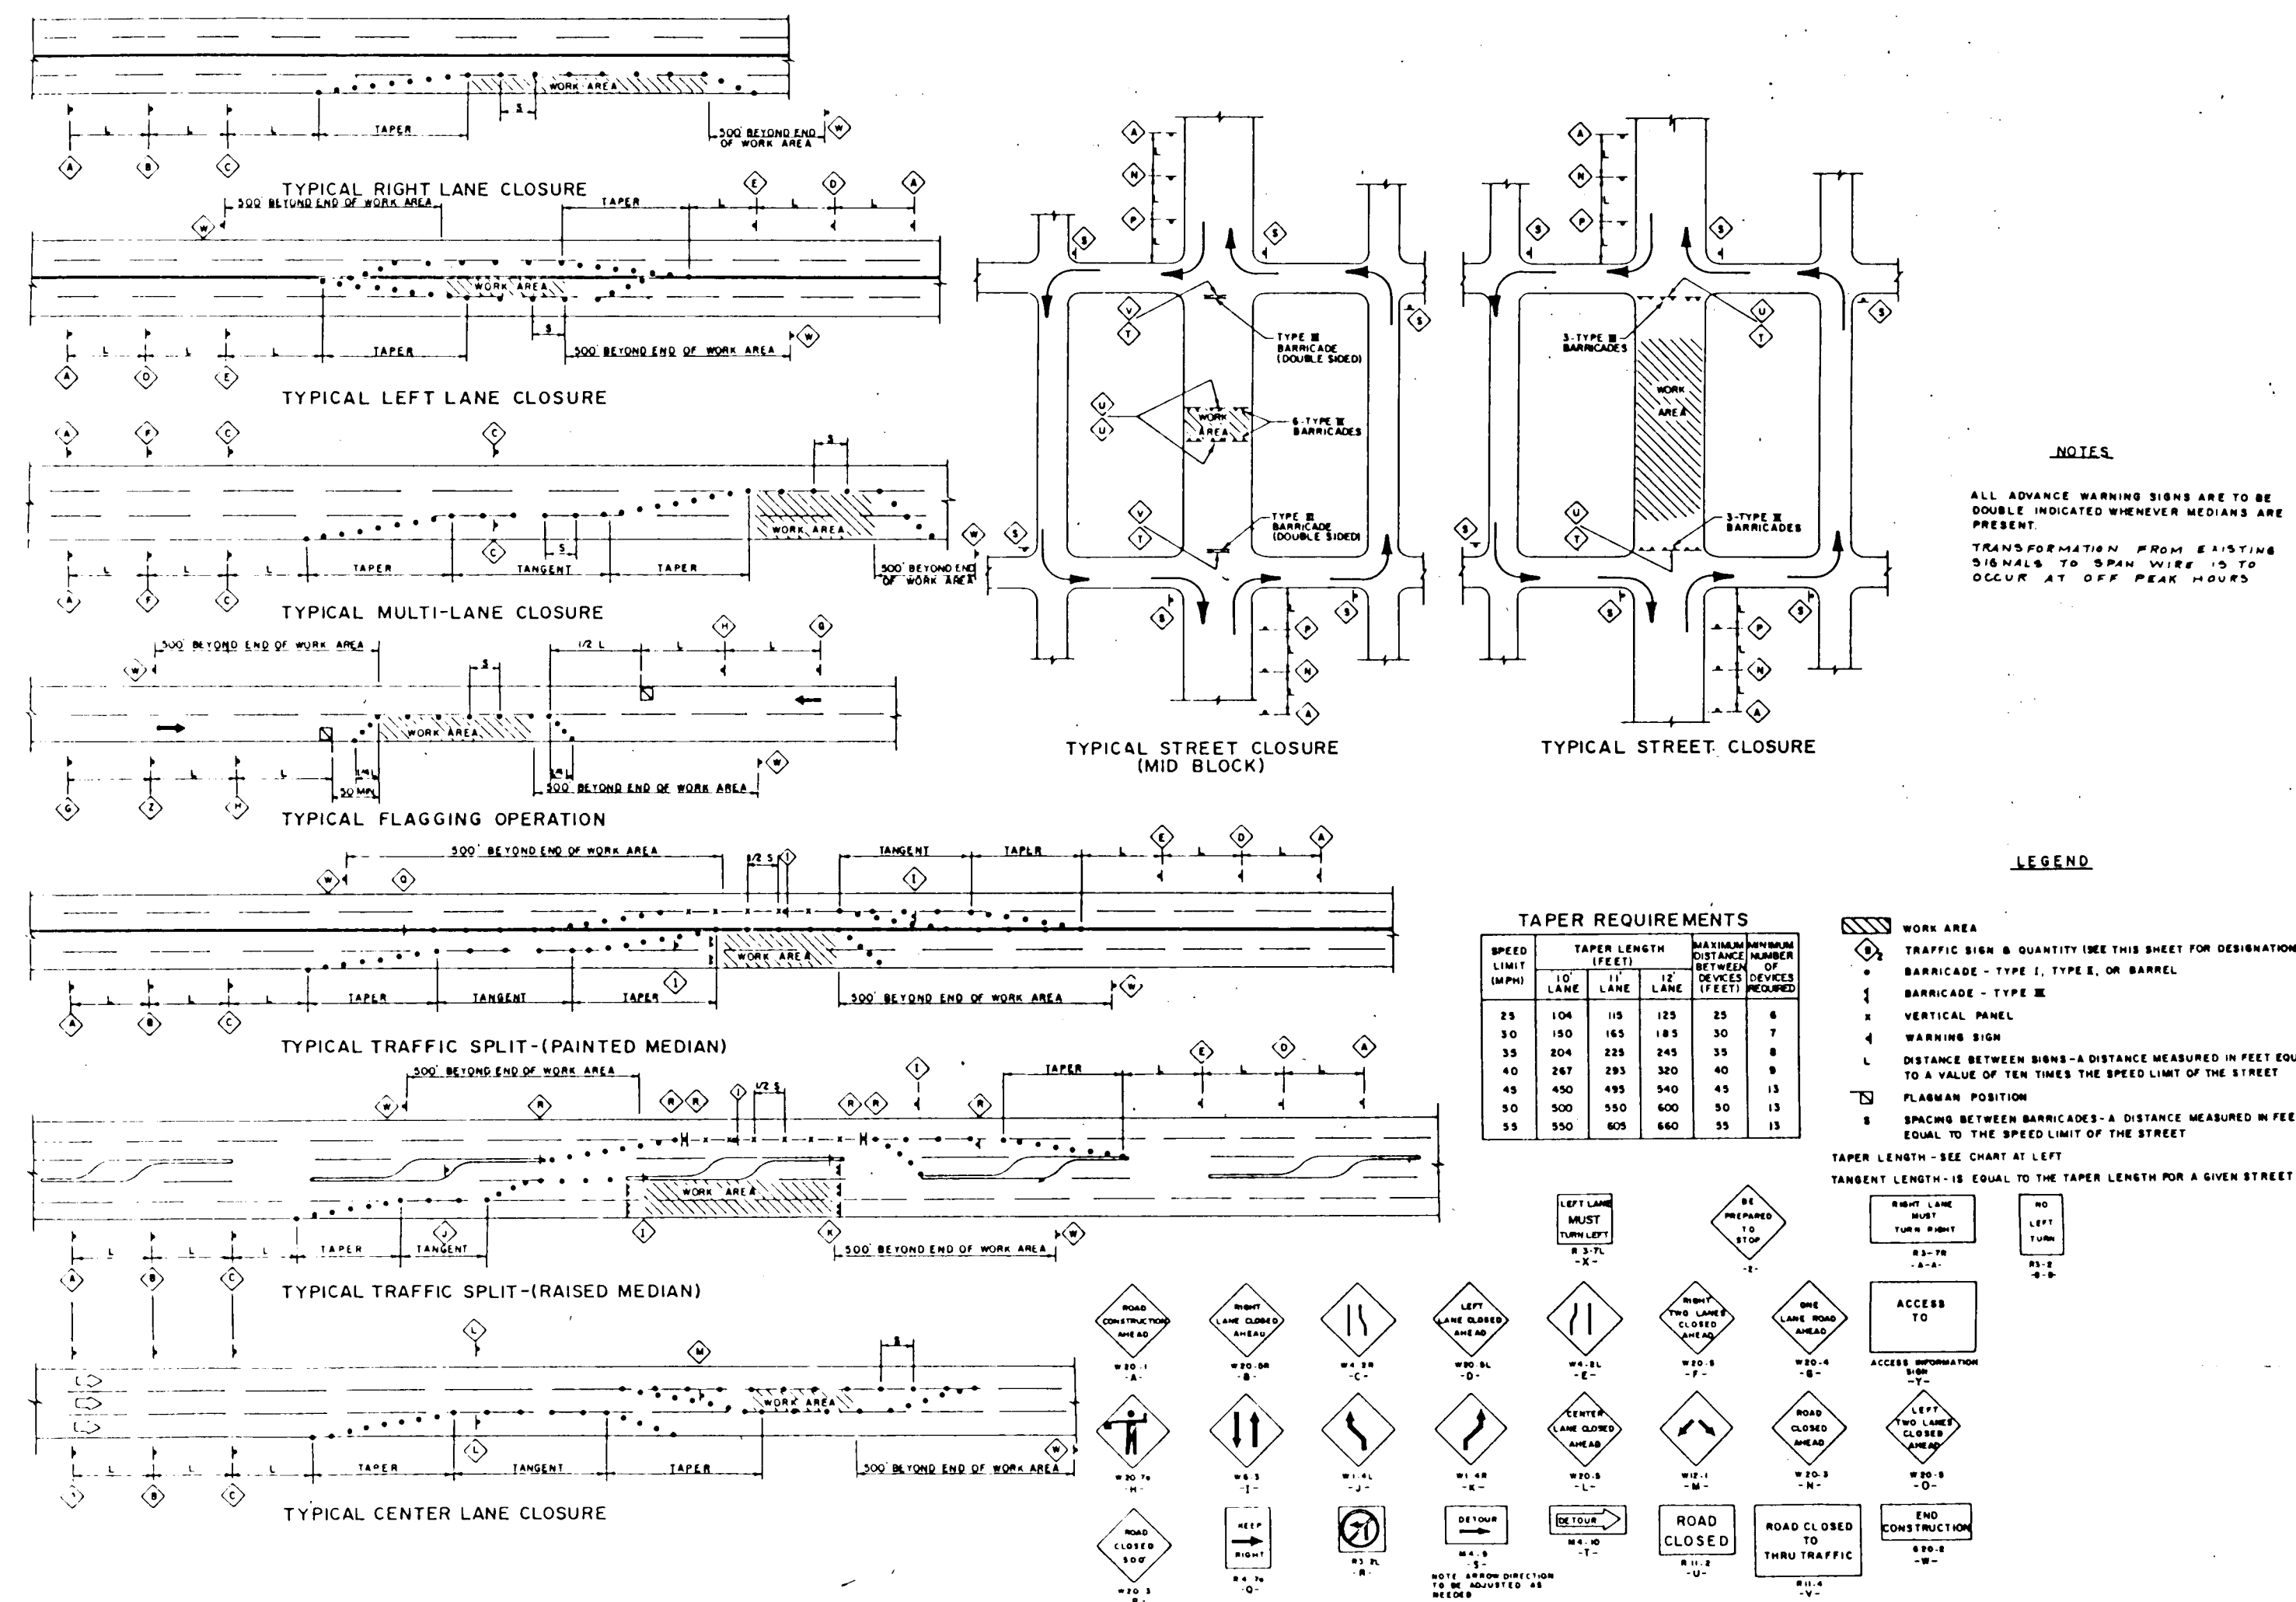

TRAFFIC CONTROL PLAN
N.T.S.

1 2 3 4 5 6 7 8 9 10 11 12
26 322904910

CITY OF ALBUQUERQUE
PUBLIC WORKS DEPARTMENT
SPECIAL ASSESSMENT DISTRICT NO. 218


TRAFFIC CONTROL PLAN

APPROVALS	ENGINEER	DATE	APPROVALS	ENGINEER	DATE
City Engineer	3-1-88	3-1-88	Liquid Waste	3-1-88	3-1-88
ACE-Design	3-1-88	3-1-88	Traffic	3-1-88	3-1-88
ACE-Hydrology	3-1-88	3-1-88	Water	3-1-88	3-1-88


DRAWING NO. 3229 MAP NO. SHEET 4 OF 52

CURVE DATA	
CURVE A	CURVE B
$\Delta = 46^\circ 34' 03''$	$\Delta = 262^\circ 13' 36''$
$R = 40.00'$	$R = 40.00'$
$L = 32.51'$	$L = 183.07'$
$T = 17.21'$	
CURVE C	
$\Delta = 35^\circ 33' 33''$	
$R = 40.00'$	
$L = 24.89'$	
$T = 12.87'$	

ACS - BH-40
NM State Plane Coords.
Control Zone
X = 352,790.66
Y = 1,492,346.53
 $\Delta = -0^\circ 16' 59''$
G/G = 0.99967105

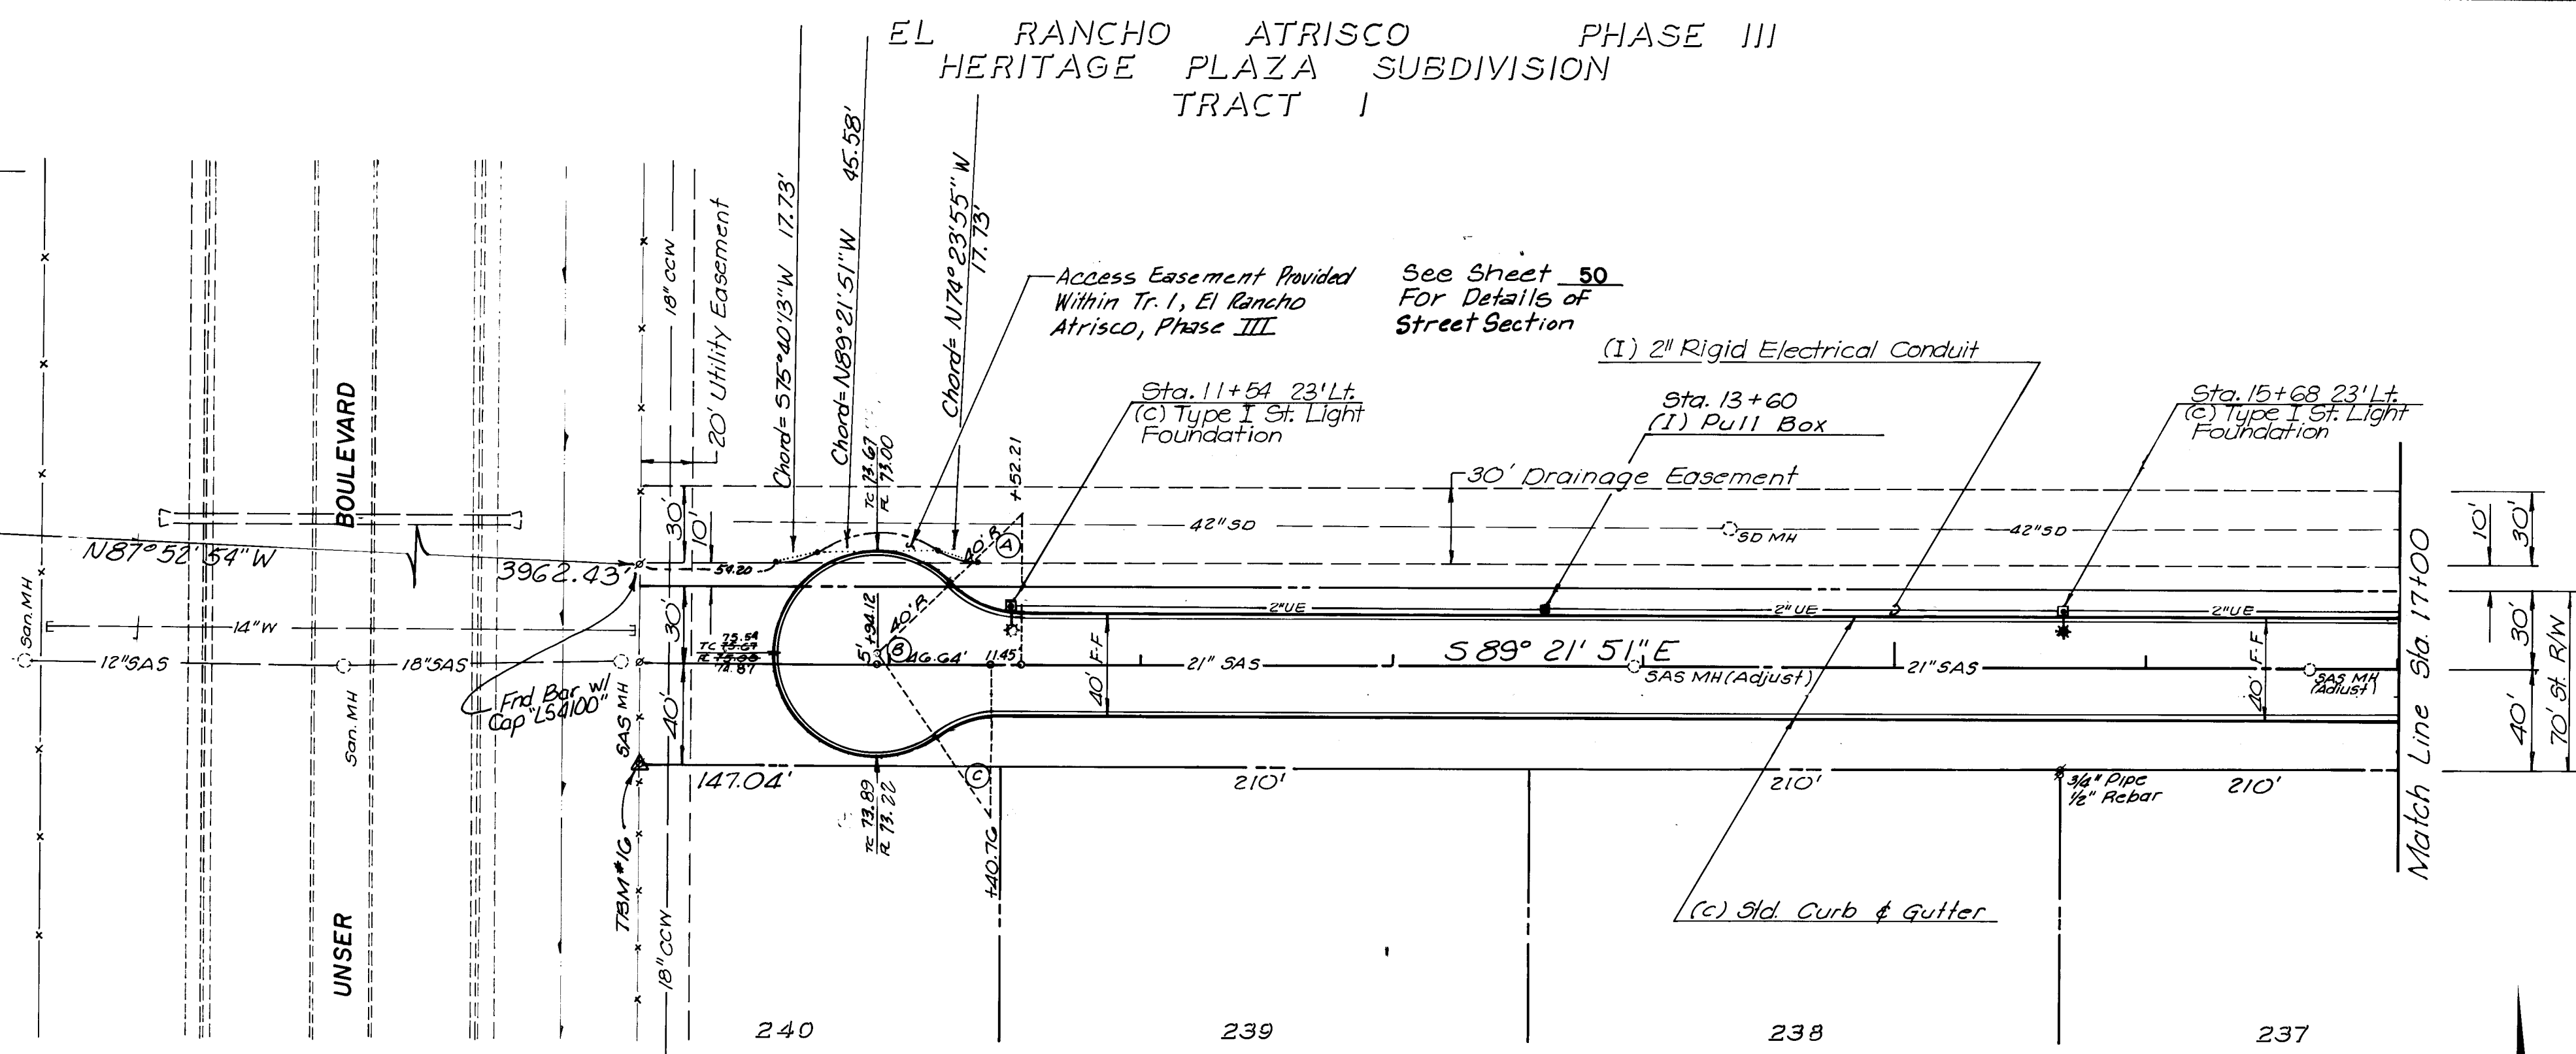

TOWN OF ATRISCO GRANT - AIRPORT UNIT

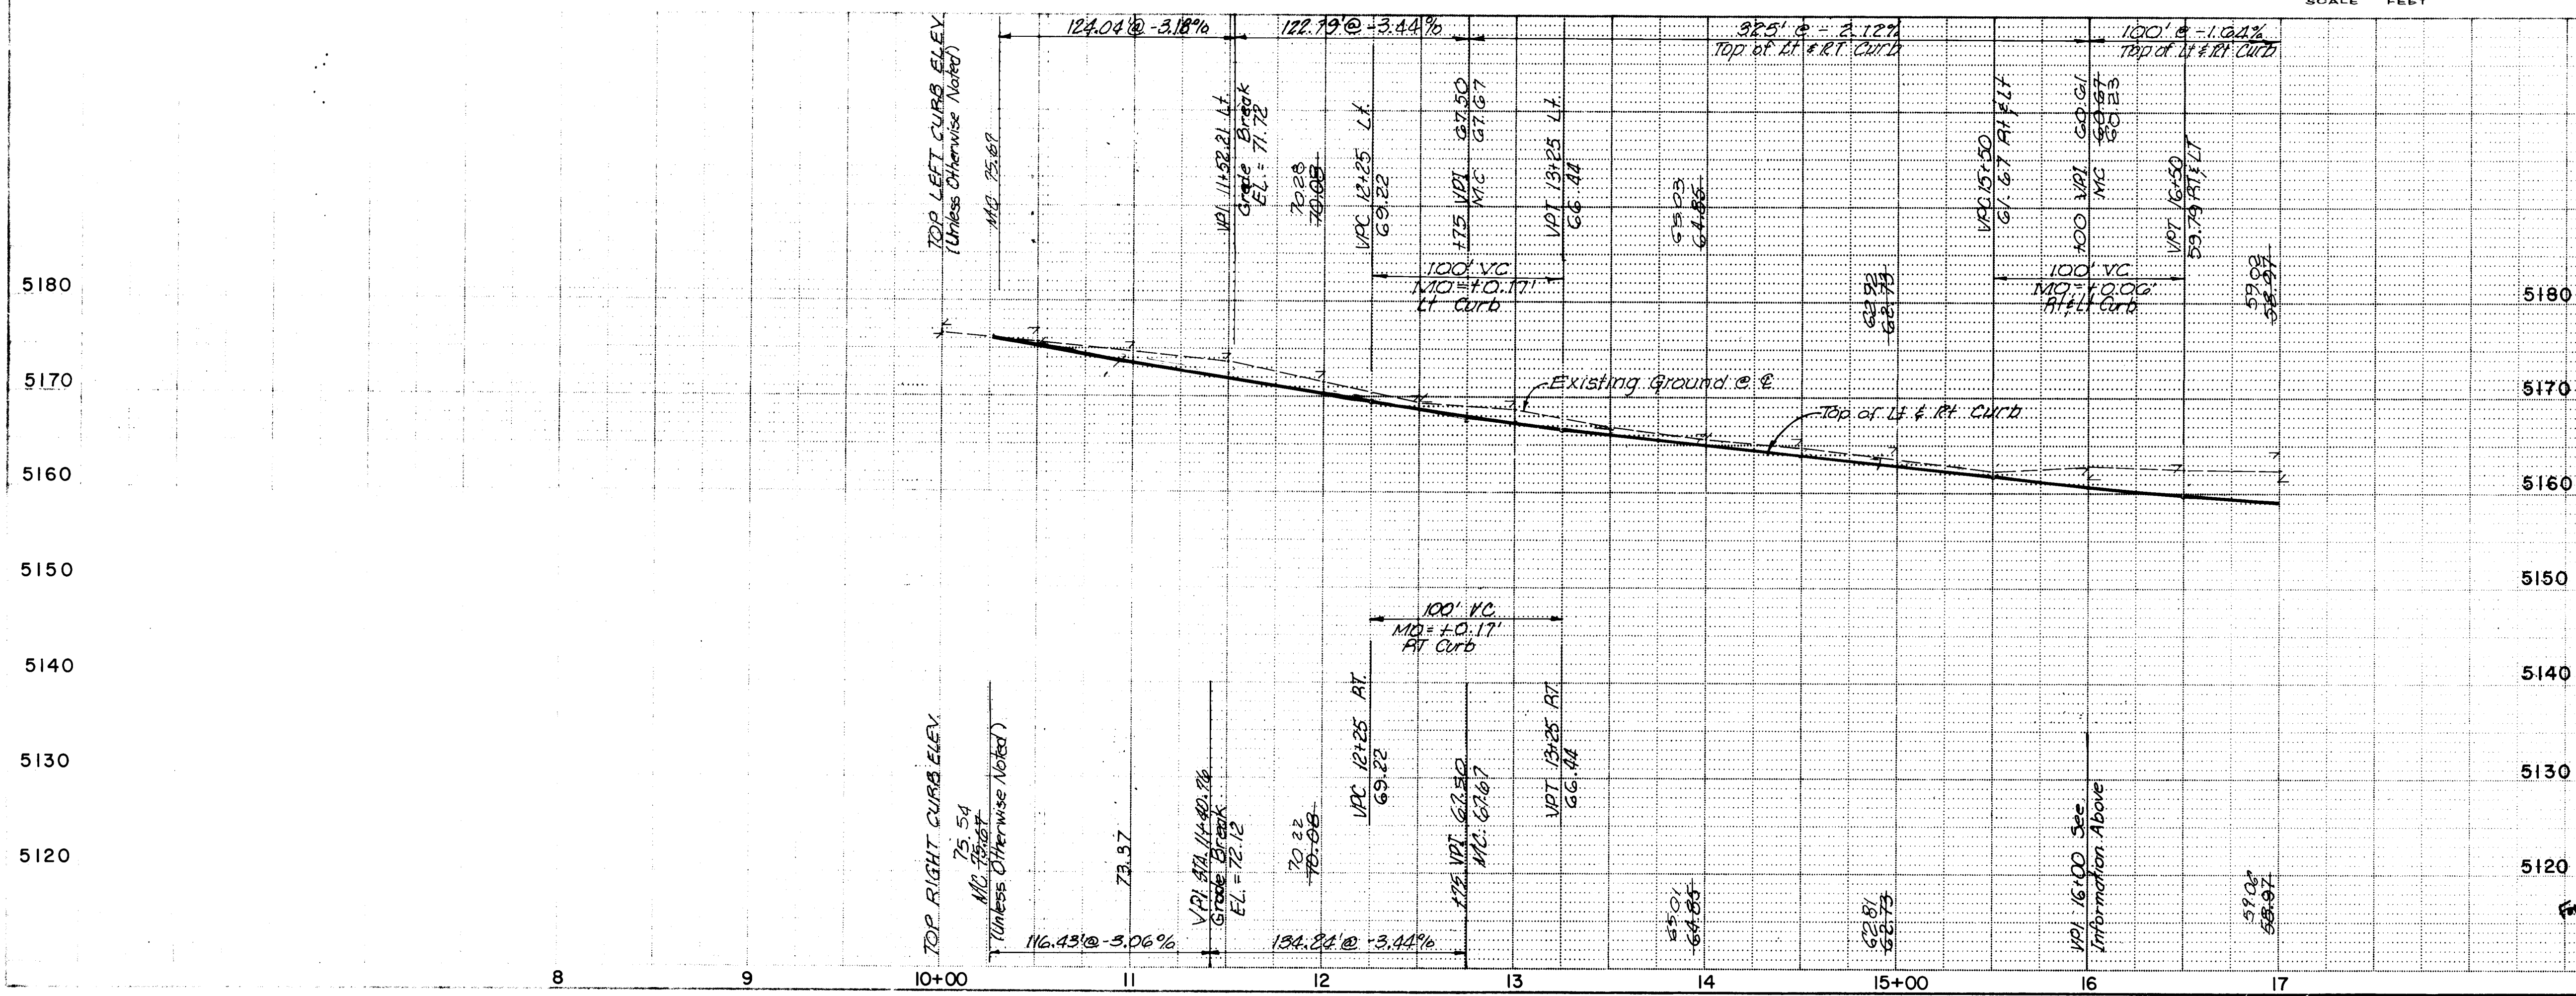

1 2 3 4 5 6 7 8 9 10 11 12
26 32 29 05 90

PAVING

CITY OF ALBUQUERQUE
PUBLIC WORKS DEPARTMENT
SPECIAL ASSESSMENT DISTRICT NO. 218

HANOVER ROAD

APPROVALS	ENGINEER	DATE	APPROVALS	ENGINEER	DATE
City Engineer	Roger A. Green	3-14-89	Liquid Waste	PEB	3/6/89
ACE - Design	"	"	Traffic	Roger A. Green	3-14-89
ACE - Hydrology	CAM	3-7-89	Water	PEB	3/6/89

DRAWING NO.	3229	MAP NO.	J-9	SHEET	5	OF	52
-------------	------	---------	-----	-------	---	----	----

LAURELWOOD SUBDIVISION UNIT 1B

Ret. Sta. 19+50.9

PT. NO.	TC	FL
3	54.25	53.58
2	54.24	53.57
1	54.22	53.57

R=30'

Ret. Sta. 20 + 76.9

PT. NO	TC	FL
3	53.92	53.25
2	53.63	52.96
1	53.35	52.68

R = 30'

Ref. Sta. 22+56.1


PT. NO	TC	FL
3	45.84	45.17
2	45.59	44.92
1	45.33	44.66

R=30'


Ret. Sta. 23+43.1

PT. NO	TC	FL
3	44.62	43.95
2	44.18	43.51
1	43.74	43.07

R = 30'

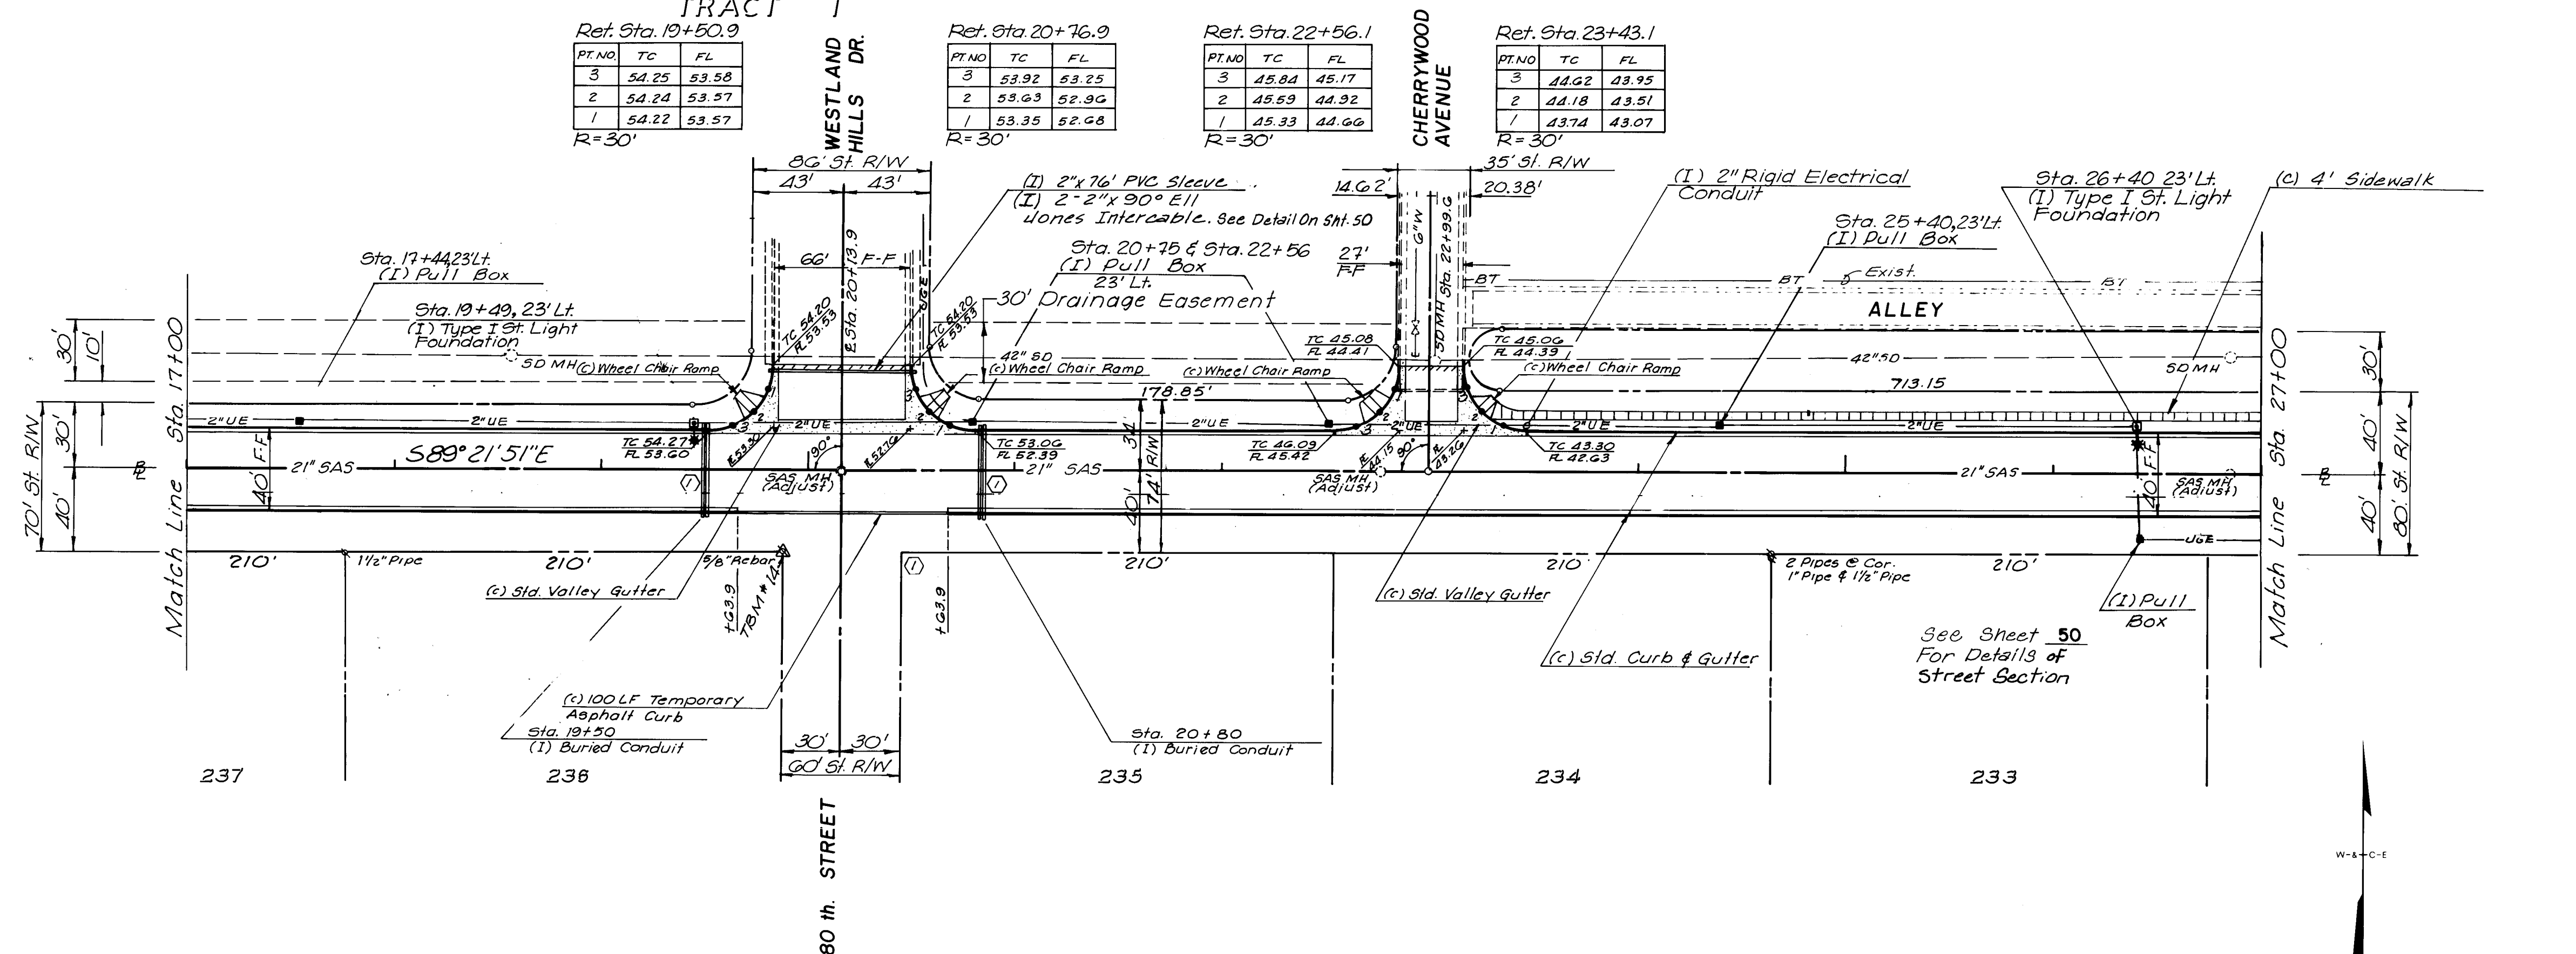

TOWN OF ATRISCO GRANT - AIRPORT UNIT

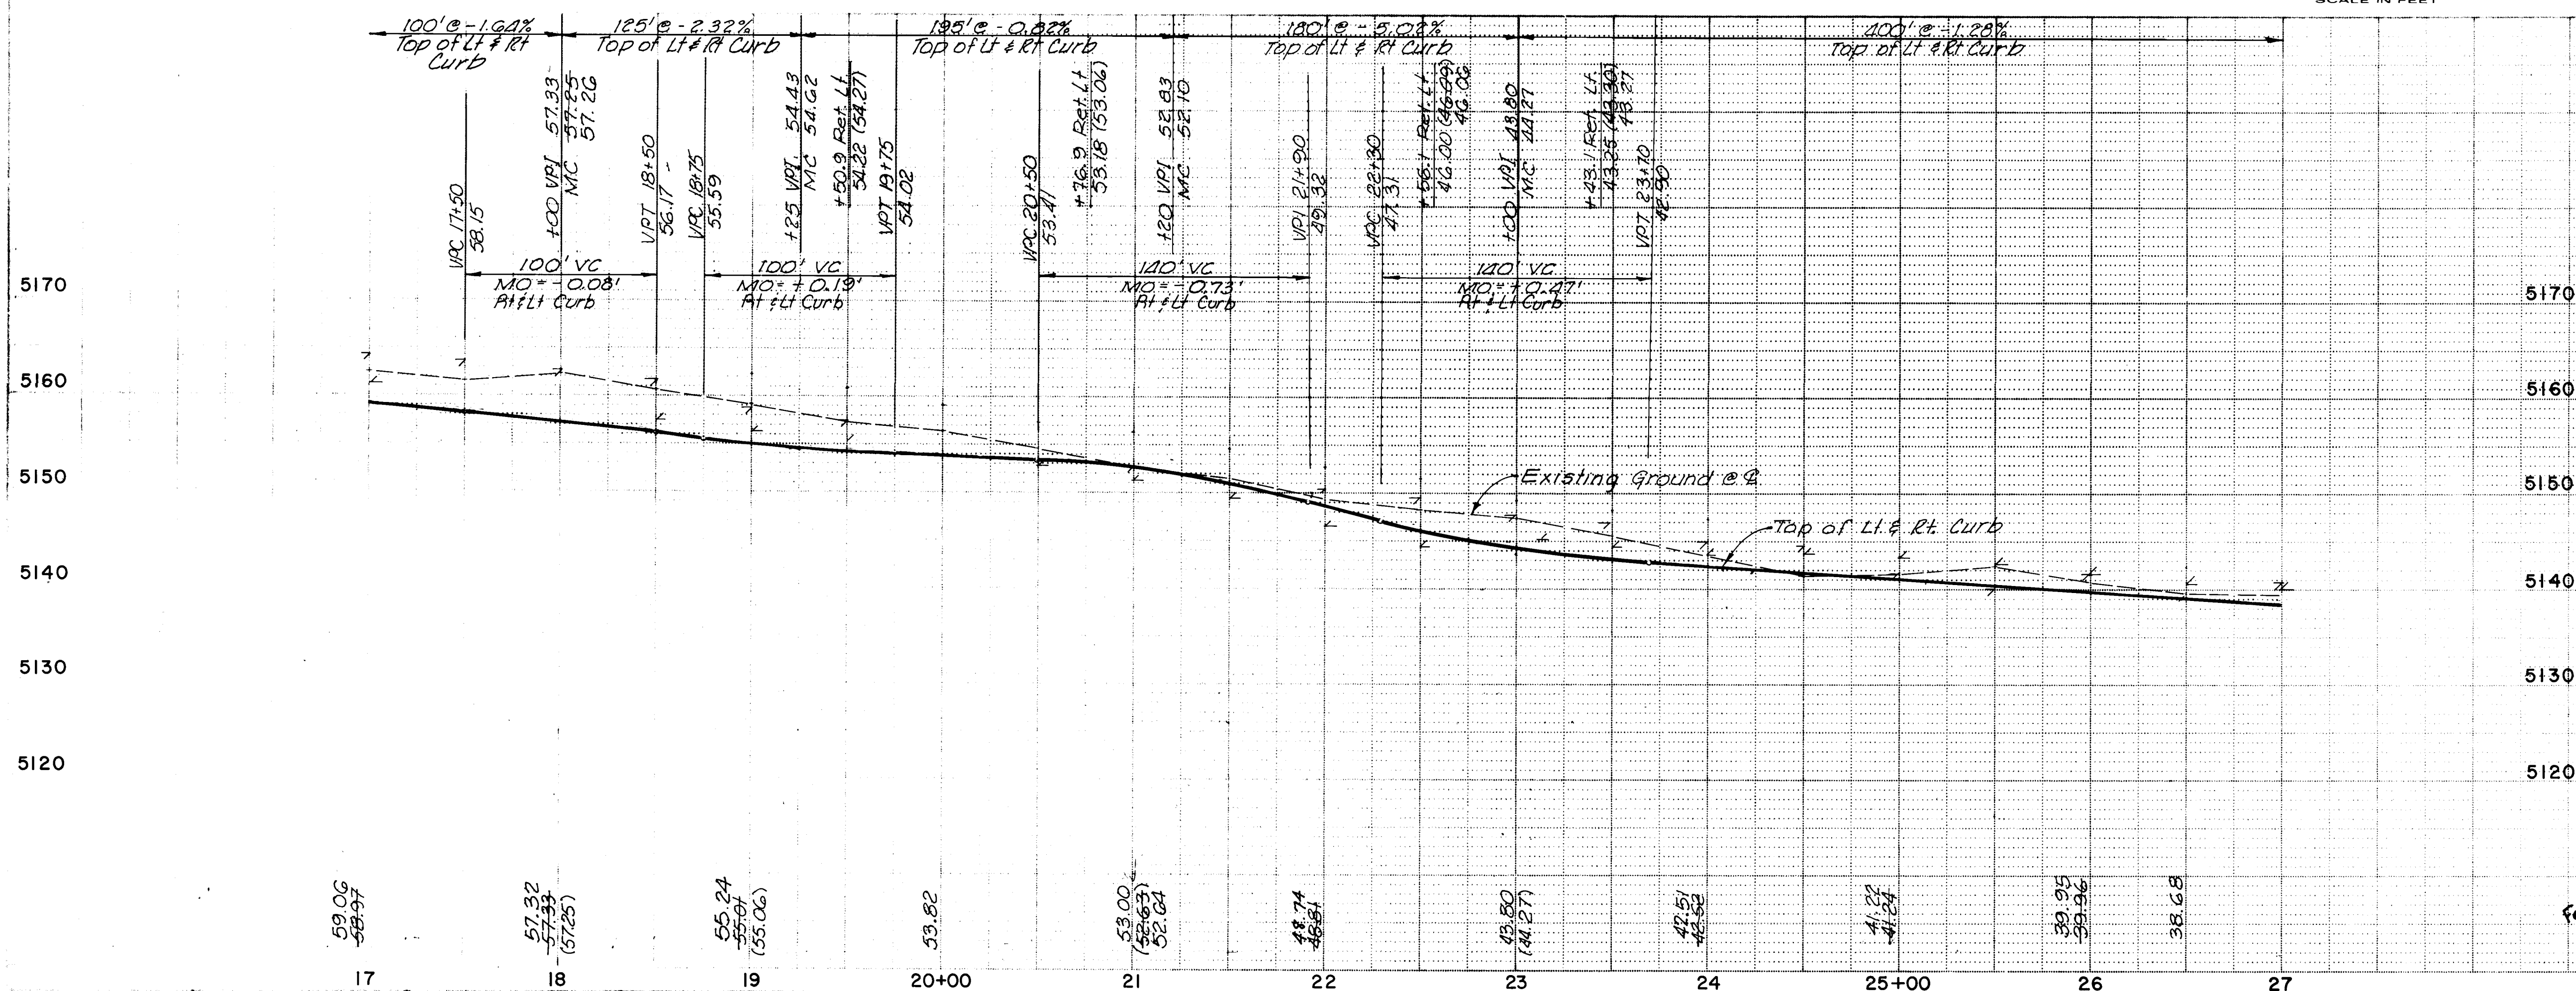

① (I) 2-4" PVC Sleeve for Buried Telephone Cable (45 L.F. Each). PVC Sleeve To Be Schedule 40.

ENGINEER'S SEAL		SURVEY INFORMATION		BENCH MARKS		AS BUILT INFORMATION	
		FIELD NOTES		TBM # 14 Sta 19+90 - 40' R 2		CONTRACTOR	
		DATE		Hanover Road 3/4" Rebar		WORK DONE BY INSPECTORS	
NO.		BY		Elevation 515.5 G3		GMA DATE: 6-89	
REMARKS		BY				ACCEPTANCE BY R. HAWLEY DATE 2-90	
NO.		DATE				FIELD VERIFICATION BY GMA DATE 12-89	
DESIGNED BY		DATE				DRAWINGS CORRECTED BY WILSON & CO DATE 3-90	
DRAWN BY		DATE				MICRO-FILM INFORMATION	
CHECKED BY		DATE				RECORDED BY	
DATE						DATE	
NO.						NO.	

PAVING

CITY OF ALBUQUERQUE
PUBLIC WORKS DEPARTMENT
SPECIAL ASSESSMENT DISTRICT NO. 218

HANOVER ROAD

APPROVALS	ENGINEER	DATE	APPROVALS	ENGINEER	DATE
City Engineer	<i>Rogers</i>	3-14-89	Liquid Waste	<i>PSO</i>	3/16/89
ACE Design	"	"	Traffic	<i>Rogers</i>	3-14-89
ACE-Hydrology	<i>AM</i>	3-7-89	Water	<i>PSO</i>	3/16/89

DRAWING NO.	3229	MAP NO. H-10 & J-10	SHEET 6	OF 52
-------------	-------------	------------------------	-------------------	-----------------


RECORD DRAWING
DATE 3-1-90

GARDNER, MASON & ASSOCIATES, INC.
ENGINEERS & PLANNERS
 ALBUQUERQUE, N.M.

87-514

LAURELWOOD SUBDIVISION UNIT 1B


PARK & DRAINAGE
MANAGEMENT AREA

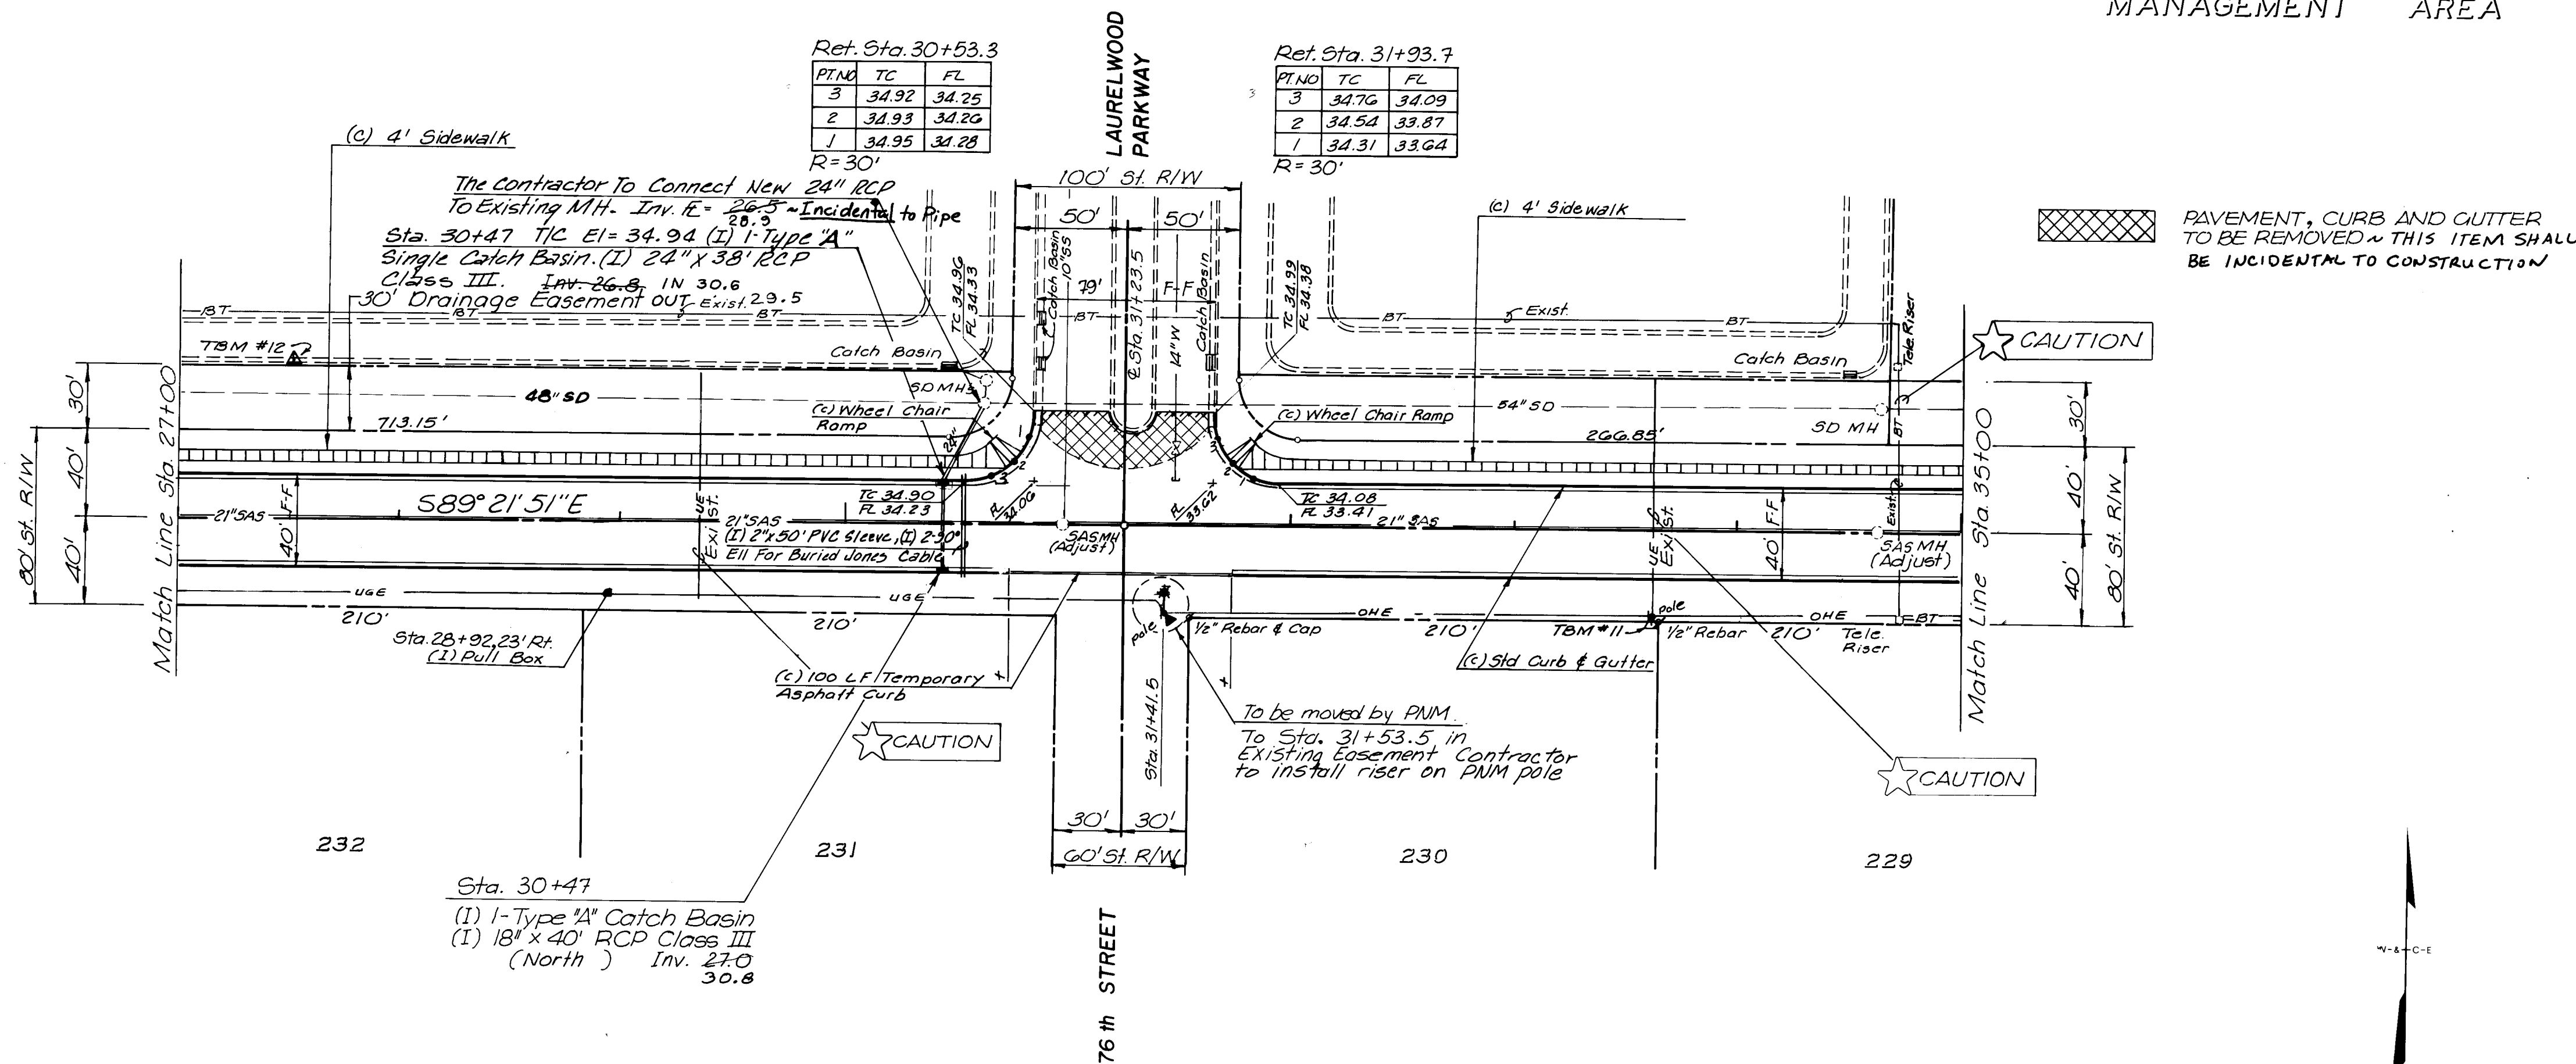

PAVEMENT, CURB AND GUTTER
TO BE REMOVED ~ THIS ITEM SHALL
BE INCIDENTAL TO CONSTRUCTION



TOWN OF ATRISCO GRANT - AIRPORT UNIT

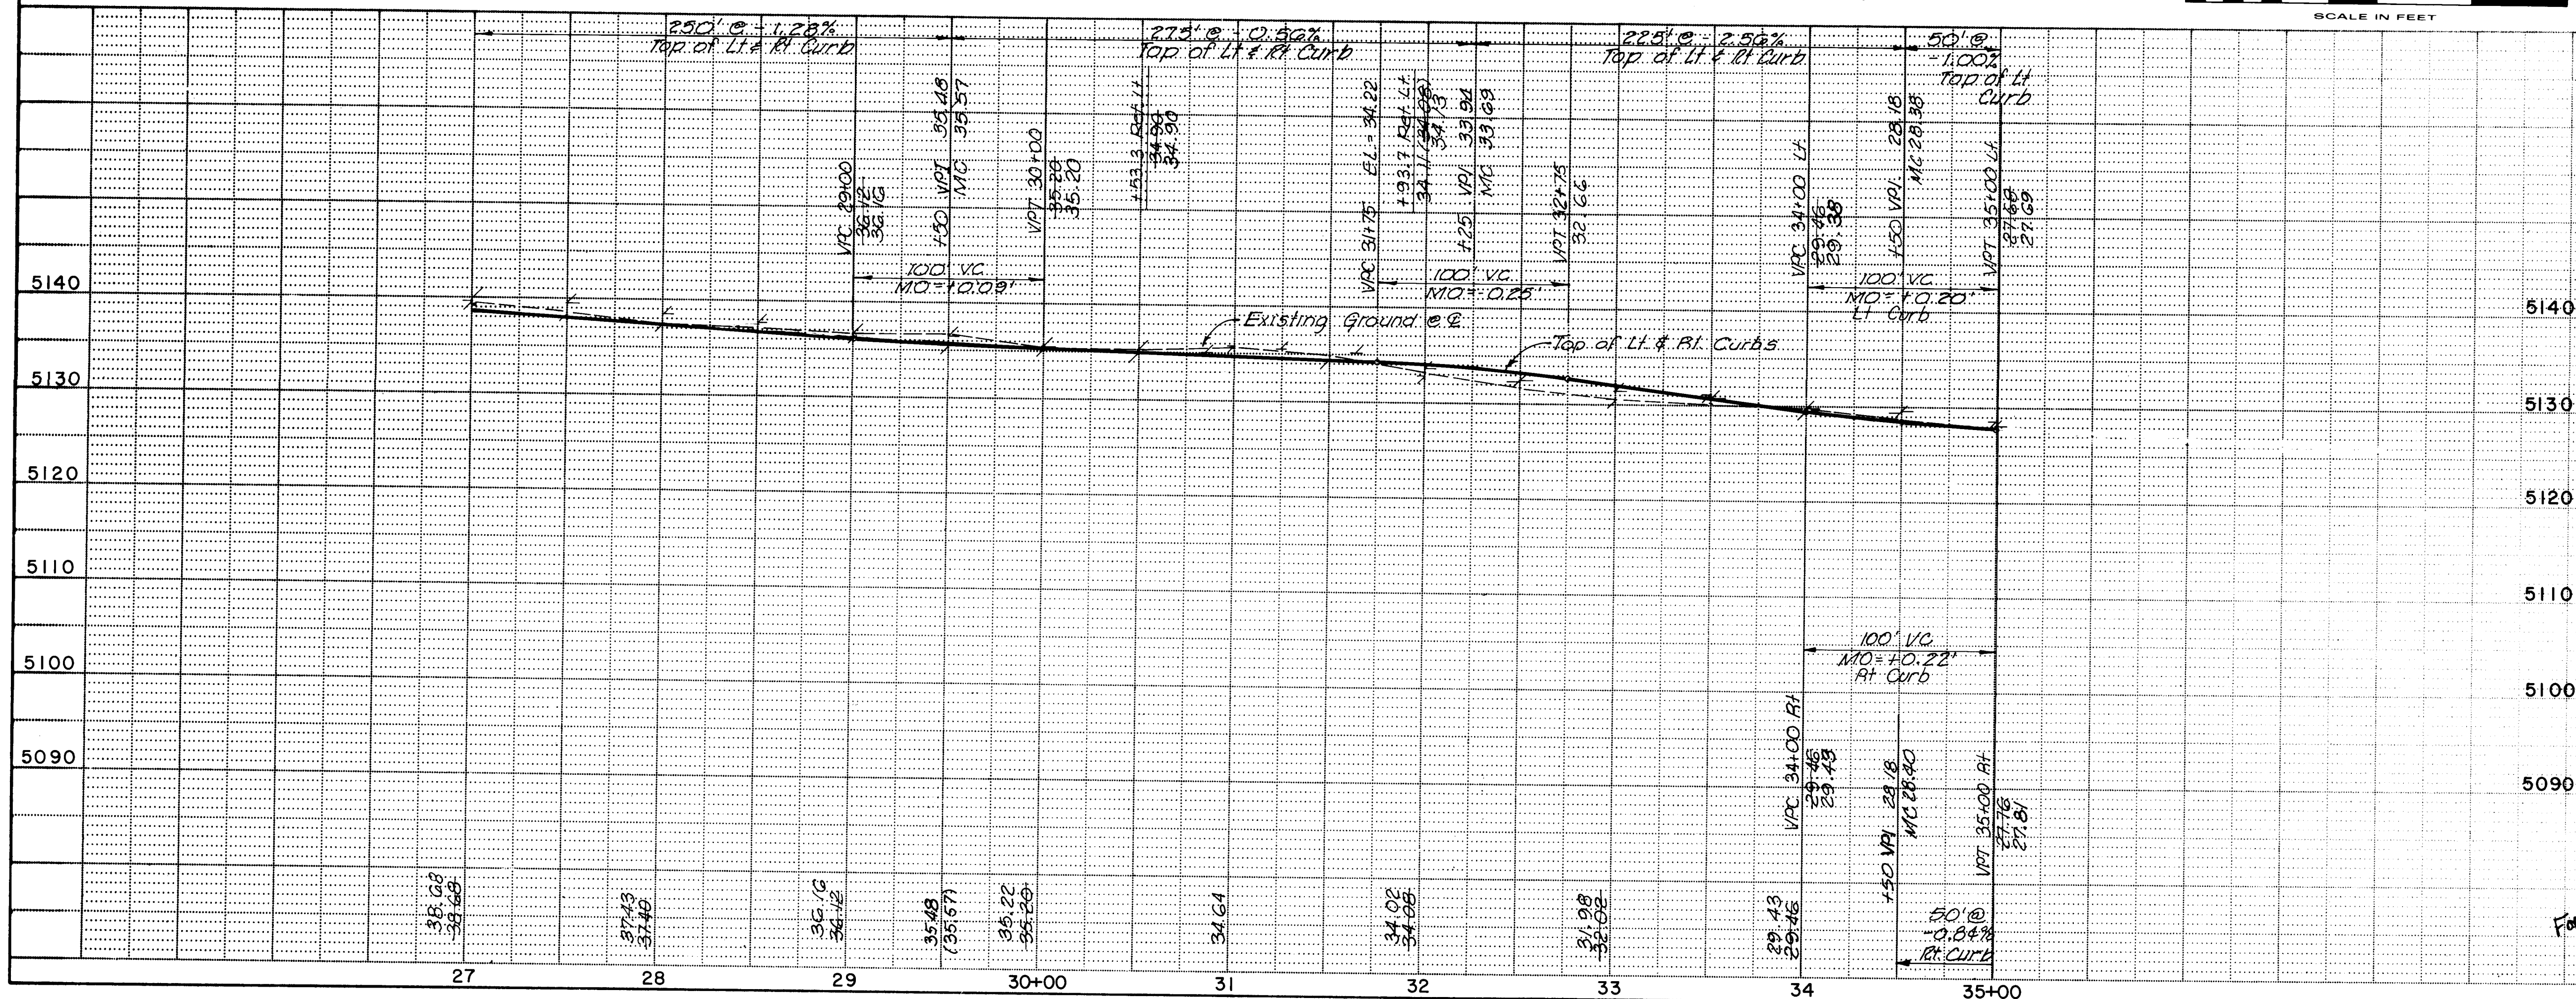

PAVING

CITY OF ALBUQUERQUE
PUBLIC WORKS DEPARTMENT
SPECIAL ASSESSMENT DISTRICT NO. 218

HANOVER ROAD

APPROVALS	ENGINEER	DATE	APPROVALS	ENGINEER	DATE
City Engineer	Reginald	3-14-89	Liquid Waste	Reginald	3/6/89
Design	Reginald	3-14-89	Traffic	Reginald	3/6/89
Hydrology	Reginald	3-7-89	Water	Reginald	3/6/89

DRAWING NO.	MAP NO.	SHEET	OF
3229	H-10 & J-10	7	52

RECORD DRAWING
DATE 3-1-90



GARDNER, MASON & ASSOCIATES, INC.
ENGINEERS & PLANNERS
ALBUQUERQUE, N.M.

WILSON & COMPANY
ENGINEERS & ARCHITECTS
ALBUQUERQUE, N.M.

87-514

<u>Curve A</u>	<u>Curve B</u>
$\Delta = 60^{\circ}00'00''$	$\Delta = 330^{\circ}00'00''$
$R = 40.00'$	$R = 40.00'$
$L = 41.89'$	$L = 230.38'$
$T = 23.09'$	

City Property
El Rancho Atrisco Phase III
Plat # C19143
Recorded 5-13-82

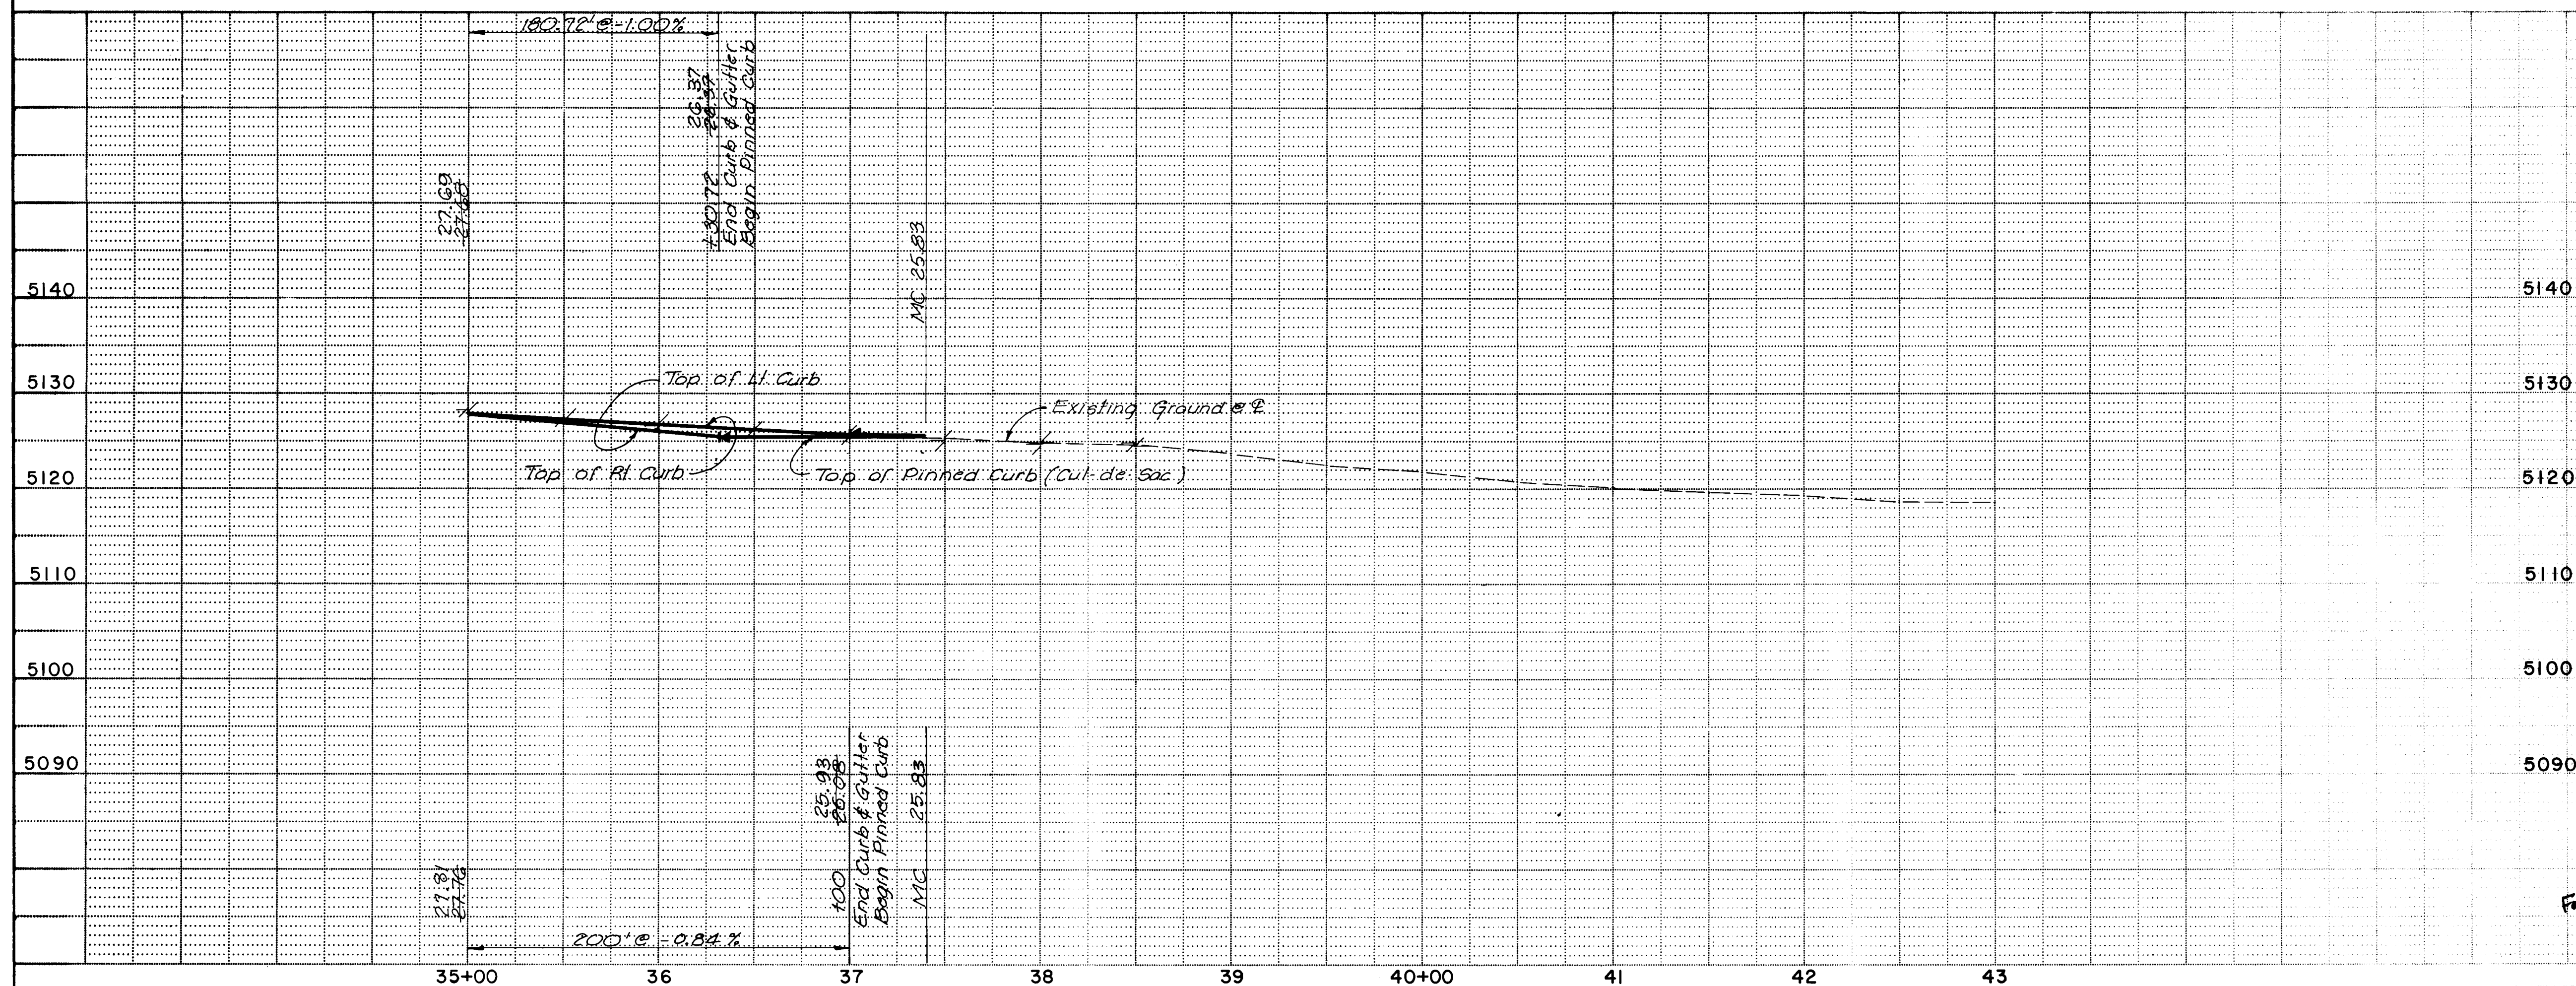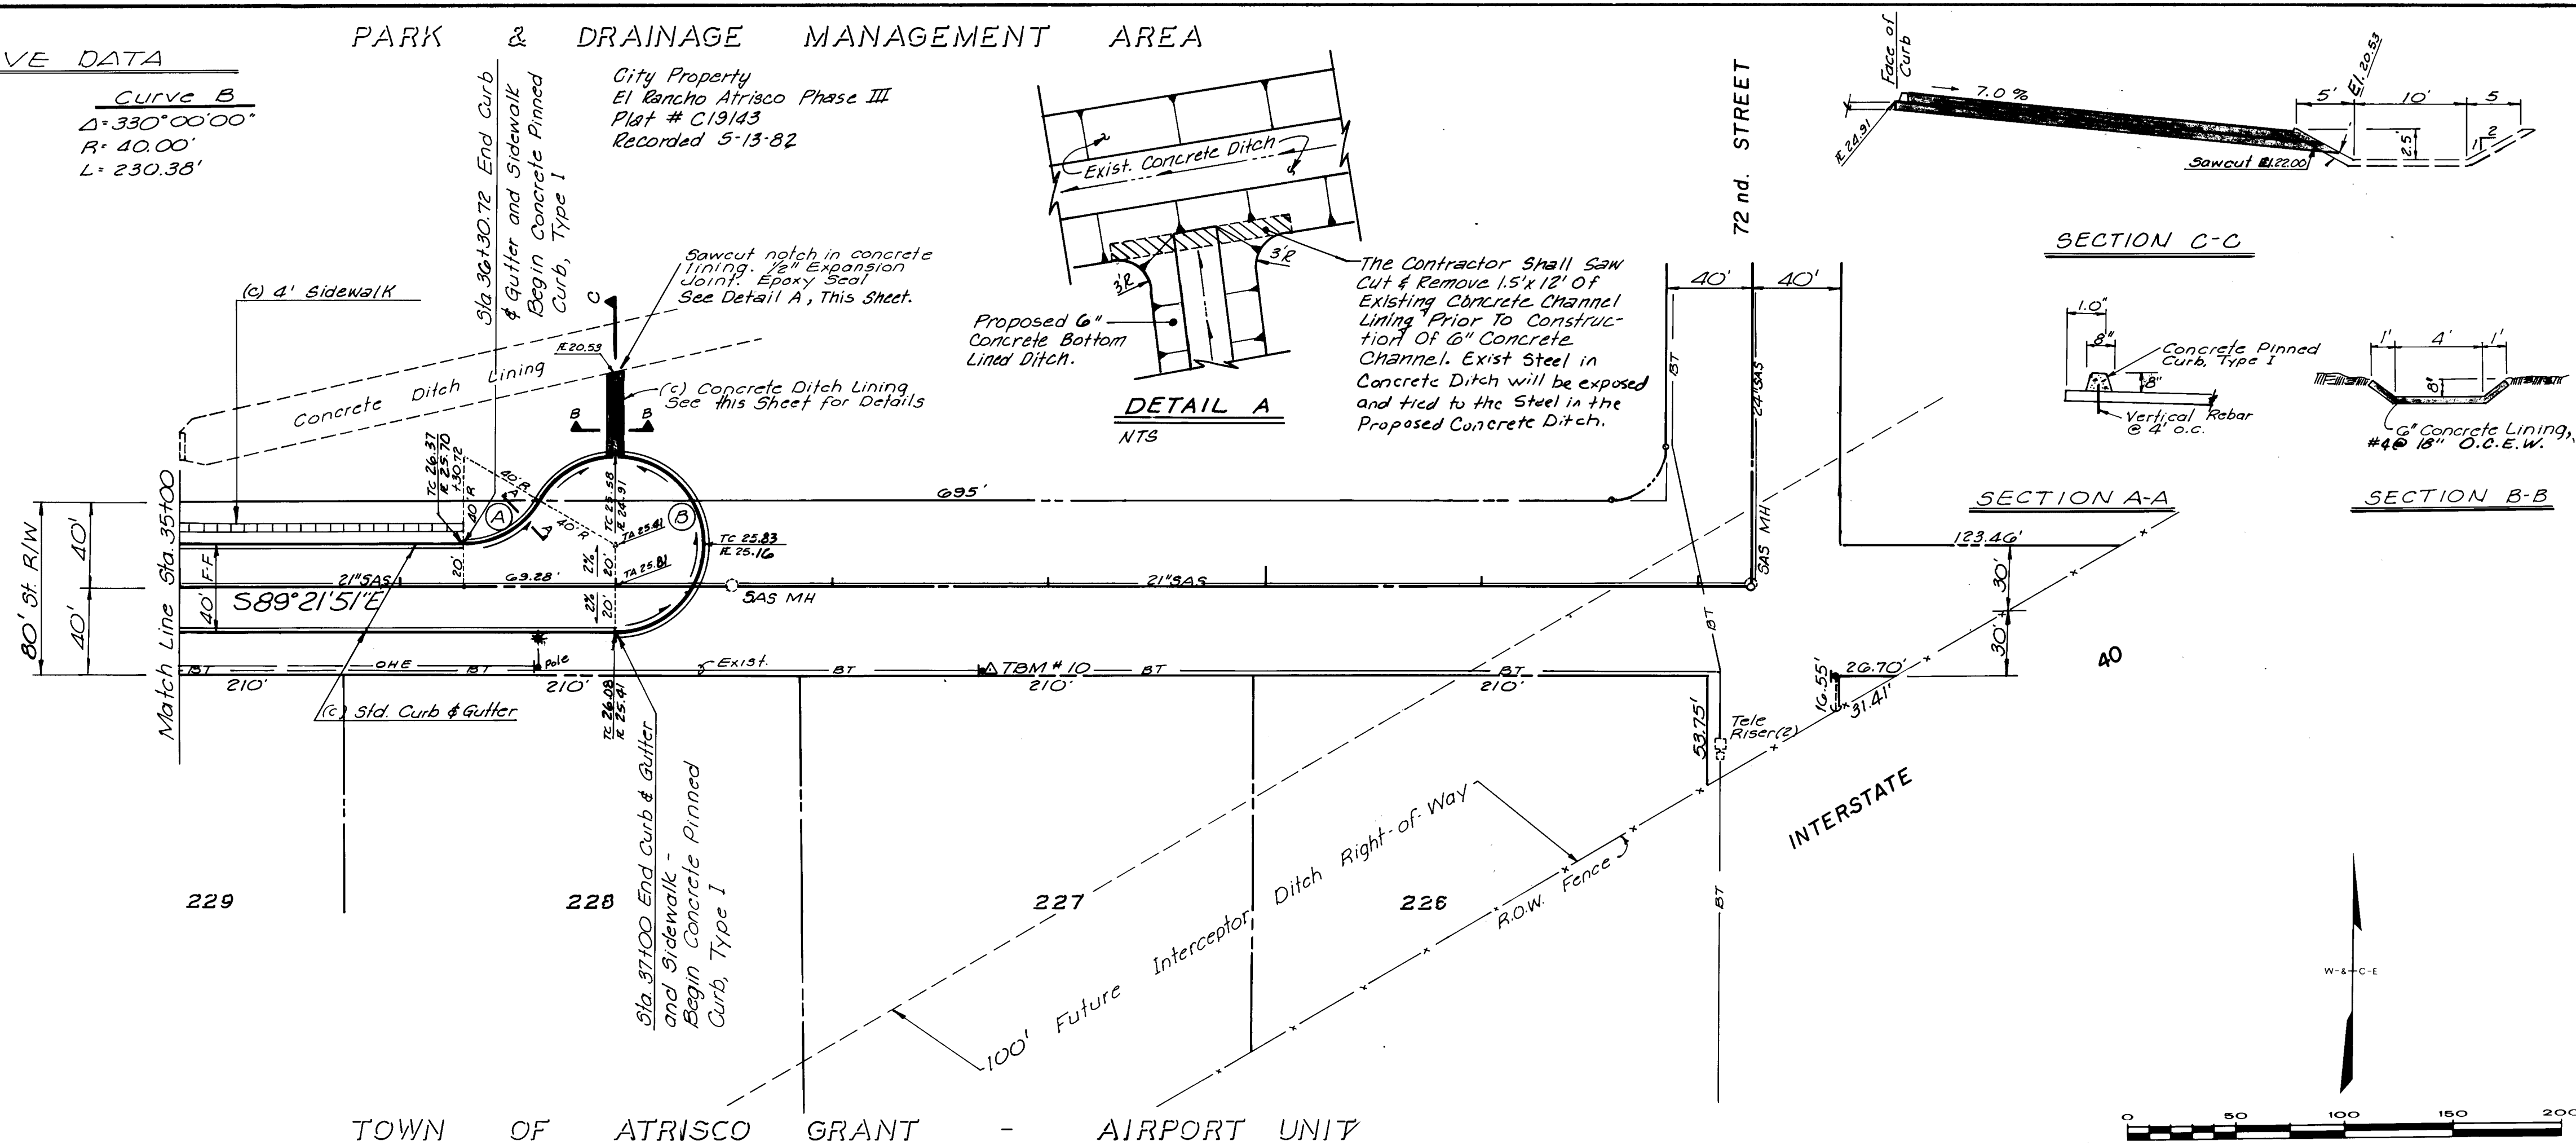

PAVING

CITY OF ALBUQUERQUE
PUBLIC WORKS DEPARTMENT
SPECIAL ASSESSMENT DISTRICT NO. 218

HANOVER ROAD

	APPROVALS	ENGINEER	DATE	APPROVALS	ENGINEER	DATE
For	City Engineer	<i>Rogers & Khan</i>	3-14-84	Liquid Waste	<i>PSO</i>	3/16/84
	ACE - Design	"	"	Traffic	<i>Rogers & Khan</i>	3-14-84
	ACE - Hydrology	<i>CAM</i>	5-7-84	Water	<i>PSO</i>	3/16/84

DRAWING NO.	3229	MAP NO.	H-10 & J-10	SHEET	8	OF	52
-------------	-------------	---------	-------------	-------	----------	----	-----------


RECORD DRAWING
DATE 3-1-90

GARDNER, MASON & ASSOCIATES, INC.
ENGINEERS & PLANNERS
ALBUQUERQUE, N.M.


WILSON & COMPANY
ENGINEERS & ARCHITECTS
ALBUQUERQUE NEW MEXICO

87-514

EL RANCHO ATRISCO PHASE III
HERITAGE PLAZA SUBDIVISION
TRACT I

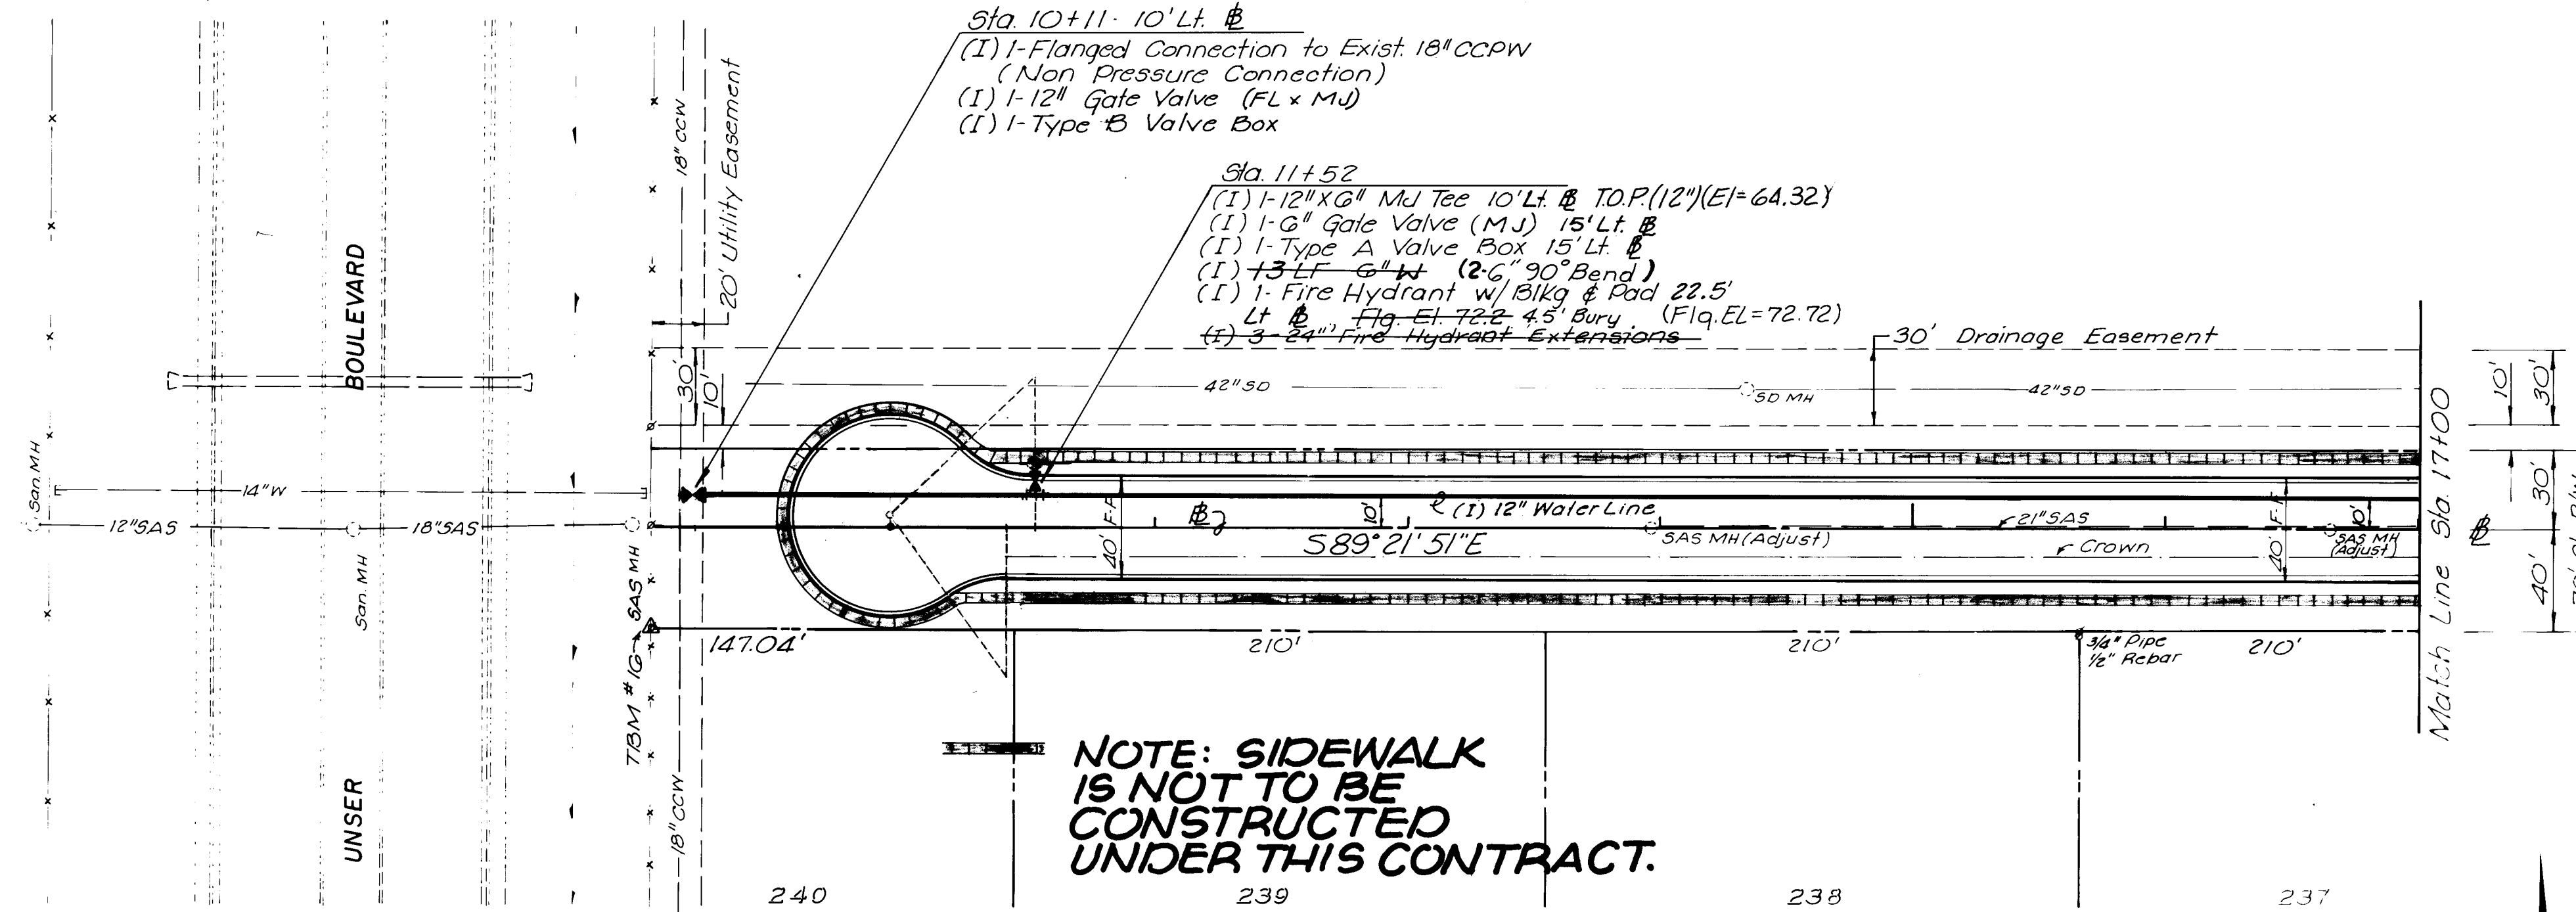

TOWN OF ATRISCO GRANT - AIRPORT UNIT

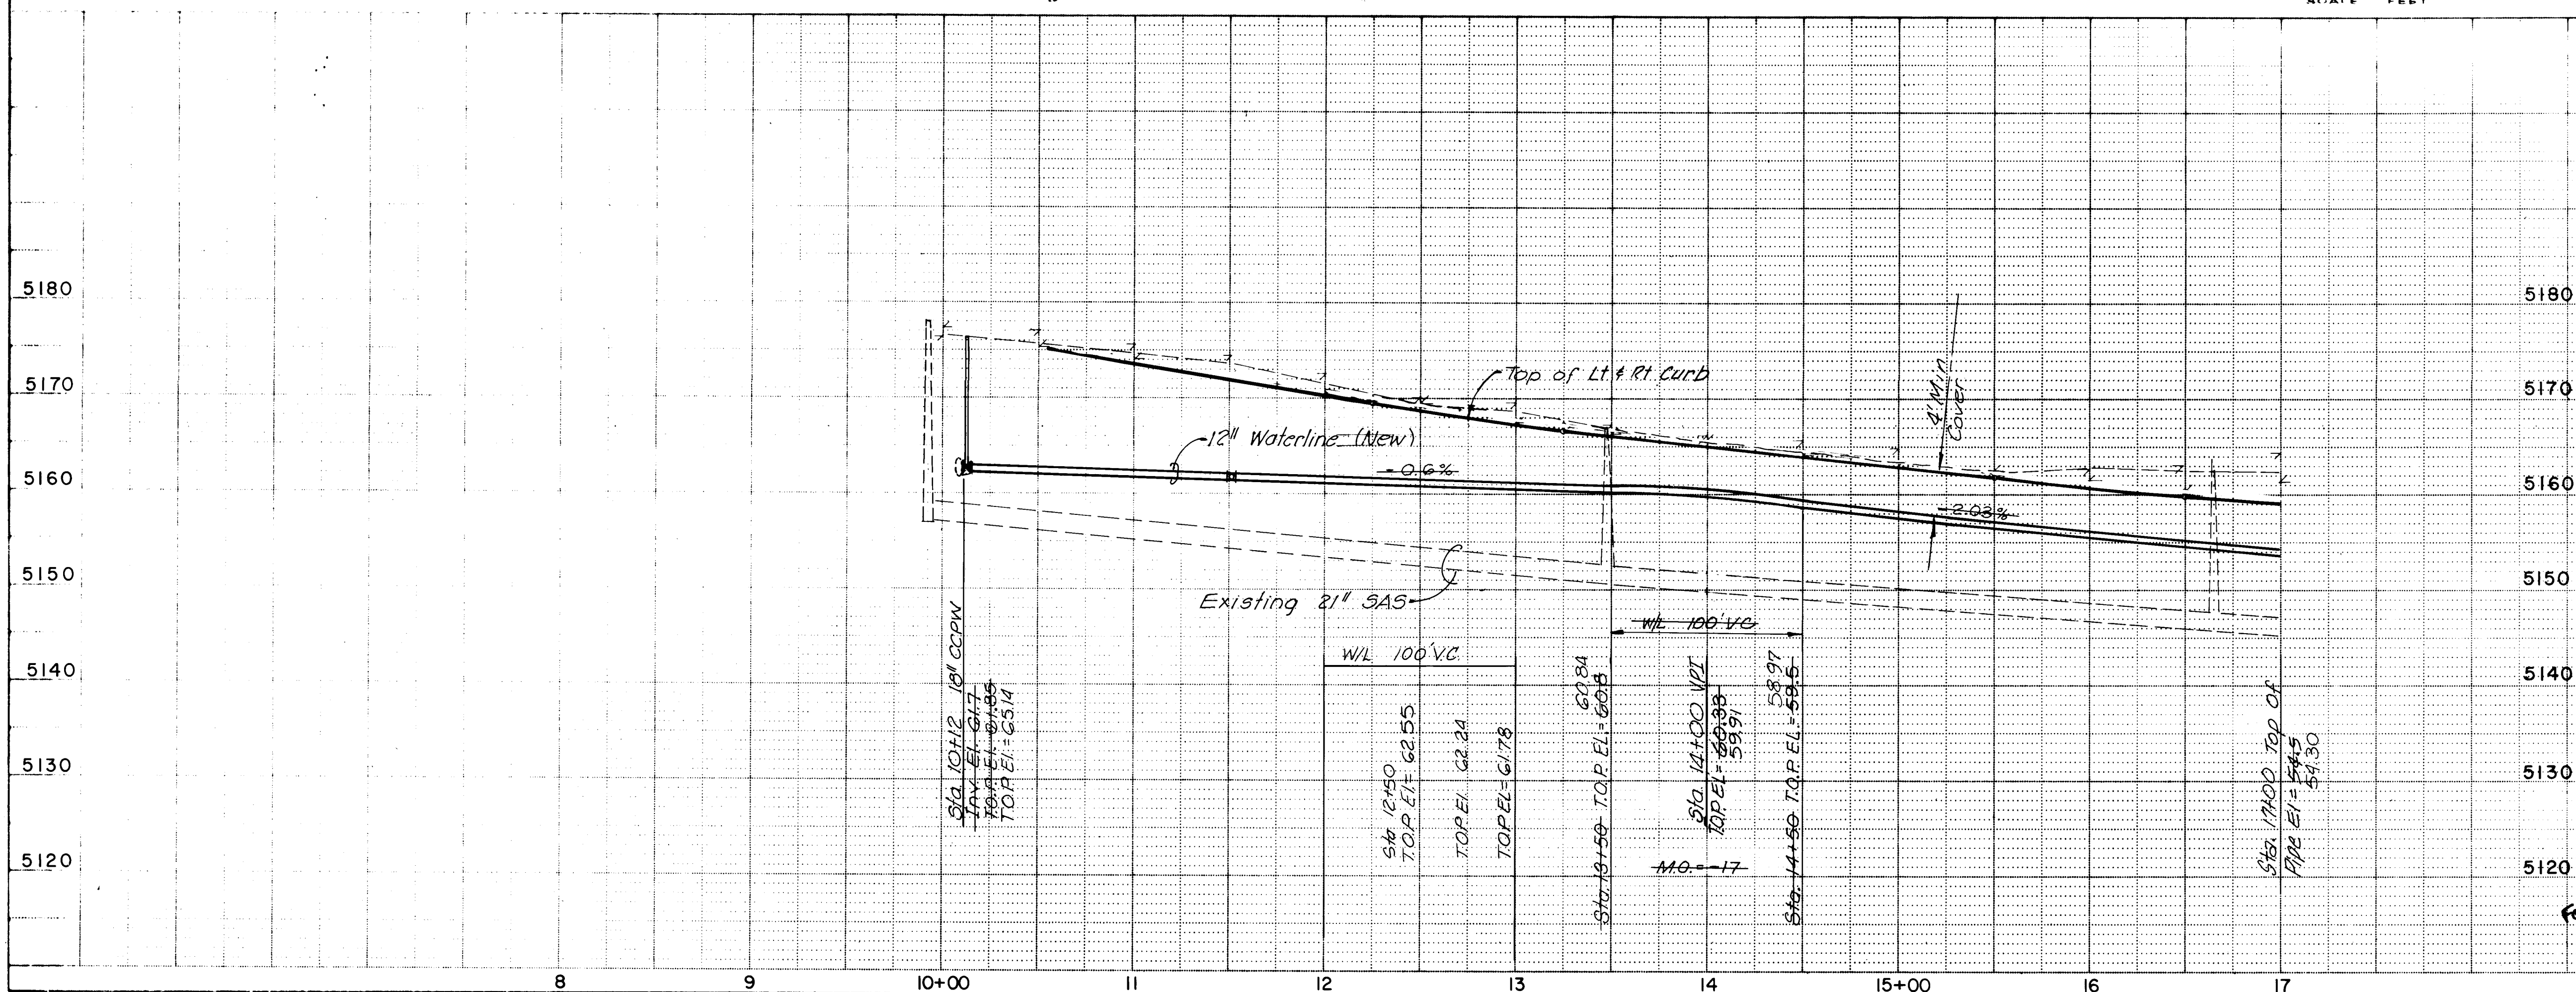

26 132290990

WATER



CITY OF ALBUQUERQUE
PUBLIC WORKS DEPARTMENT
SPECIAL ASSESSMENT DISTRICT NO. 218

HANOVER ROAD

APPROVALS	ENGINEER	DATE	APPROVALS	ENGINEER	DATE
City Engineer	Donna Rhea	3-14-89	Liquid Waste	Donna Rhea	3-14-89
AGE - Design	u	11	Traffic	Donna Rhea	3-14-89
AGE - Hydrology	CAM	5-7-89	Water	Donna Rhea	3-14-89

DRAWING NO.	3229	MAP NO.	J-9	SHEET	9	OF	52
-------------	------	---------	-----	-------	---	----	----

RECORD DRAWING
DATE 3-1-90

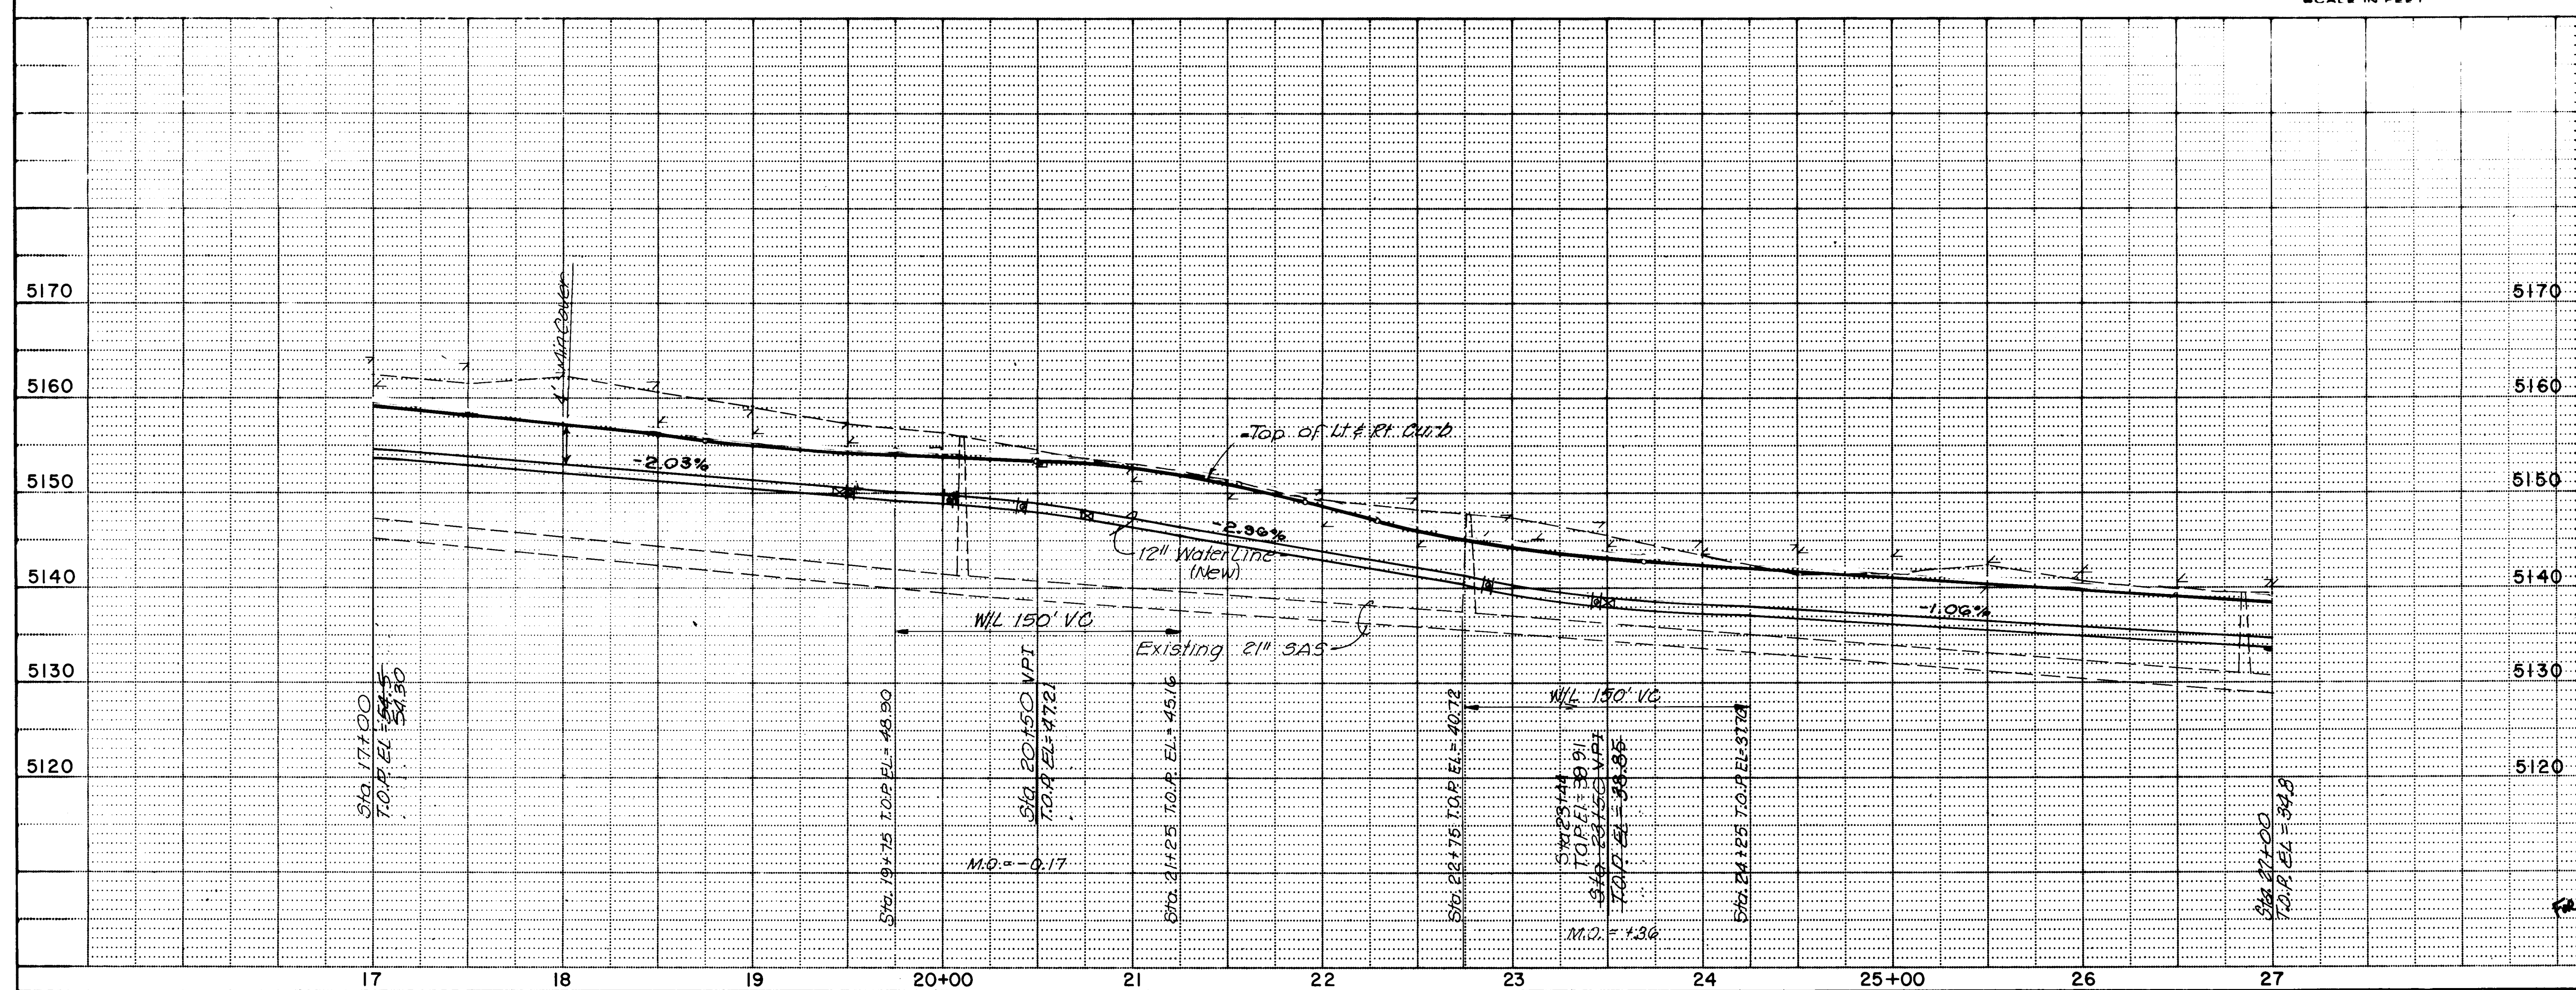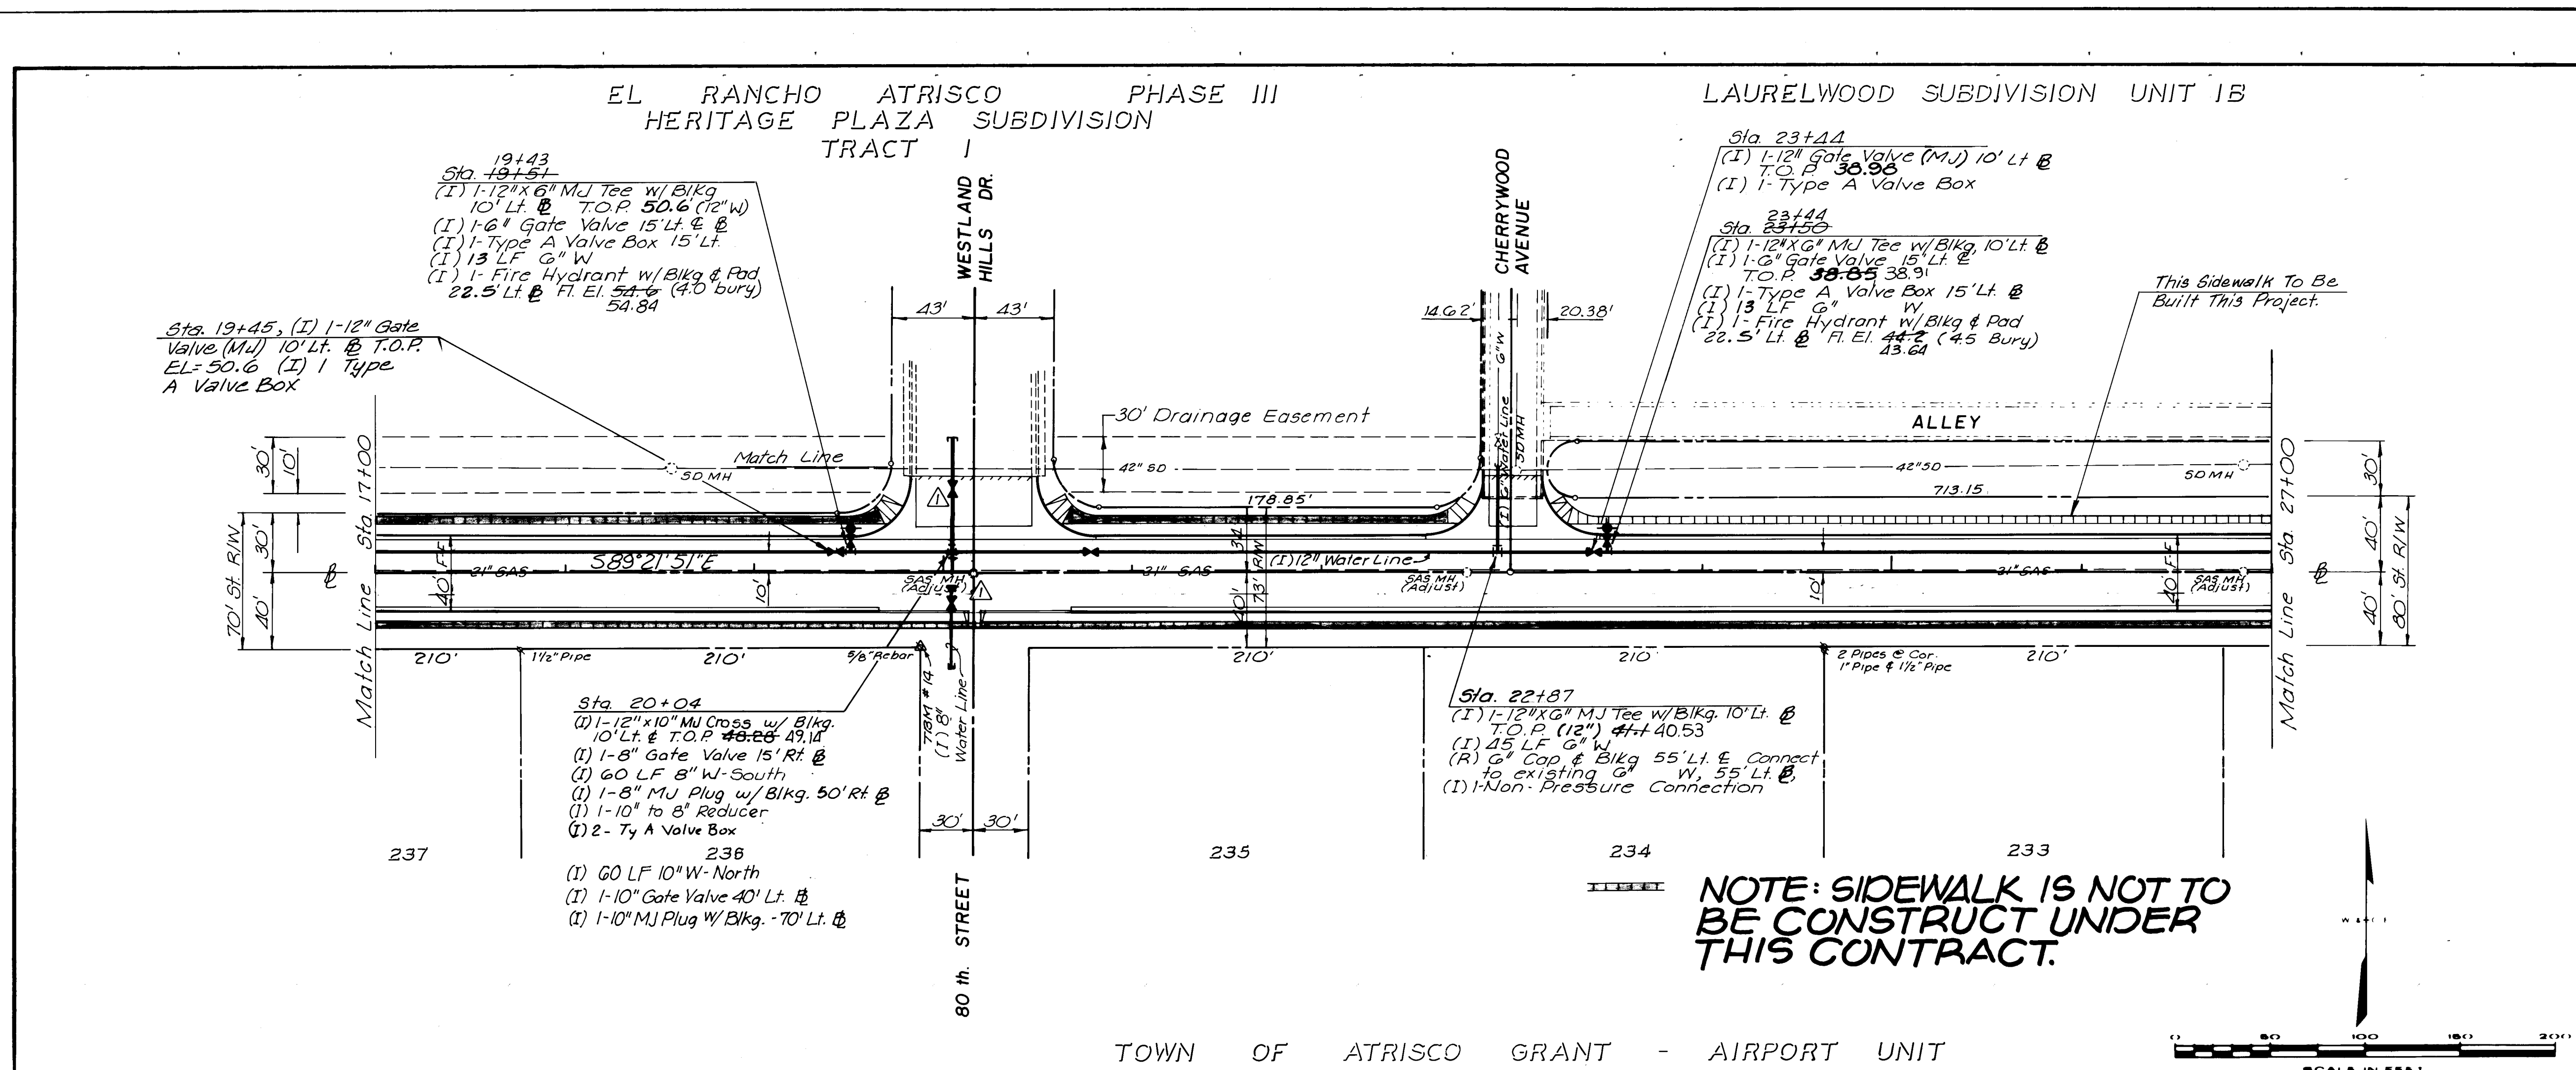

AS BUILT INFORMATION			BENCH MARKS			SURVEY INFORMATION			ENGINEER'S SEAL		
CONTRACTOR	UNIVERSAL CONSTRUCTION	DATE	NO.	DATE	BY	NO.	DATE	BY	NO.	DATE	BY
CONTRACTOR	UNIVERSAL CONSTRUCTION	DATE	NO.	DATE	BY	NO.	DATE	BY	NO.	DATE	BY
INSPECTOR	GMA	DATE	NO.	DATE	BY	NO.	DATE	BY	NO.	DATE	BY
ACCEPTANCE	DATE	BY	NO.	DATE	BY	NO.	DATE	BY	NO.	DATE	BY
VERIFICATION	DATE	BY	NO.	DATE	BY	NO.	DATE	BY	NO.	DATE	BY
CORRECTION	DATE	BY	NO.	DATE	BY	NO.	DATE	BY	NO.	DATE	BY
RECORD	DATE	BY	NO.	DATE	BY	NO.	DATE	BY	NO.	DATE	BY

REVISIONS		
NO.	DATE	REMARKS
1	3/21/89	Revised Water Valve
2	3/22/89	
3	3/22/89	
4	3/22/89	
5	3/22/89	
6	3/22/89	
7	3/22/89	
8	3/22/89	
9	3/22/89	
10	3/22/89	
11	3/22/89	
12	3/22/89	

DESIGNED BY			CHECKED BY		
NO.	DATE	BY	NO.	DATE	BY
DESIGNED BY	DATE	BY	NO.	DATE	BY
CHECKED BY	DATE	BY	NO.	DATE	BY


APPROVALS			ENGINEER			DATE		
City Engineer	DATE	Signature	City Engineer	DATE	Signature	City Engineer	DATE	Signature
City Engineer	3-1-89	Signature	City Engineer	3-1-89	Signature	City Engineer	3-1-89	Signature
ACE-Design	"	"	ACE-Design	"	"	ACE-Design	"	"
ACE-Hydrology	CAM	NA	ACE-Hydrology	8-7-89	Water	ACE-Hydrology	8-7-89	Water

DRAWING NO.	MAP NO.	SHEET	OF
3229	H-10 & J-10	10	52

RECORD DRAWING		DATE	
RECORD DRAWING	DATE	RECORD DRAWING	DATE
3-1-89	3-1-89	3-1-89	3-1-89


GARDNER, MASON & ASSOCIATES, INC.		WILSON & COMPANY	
ENGINEERS & PLANNERS	ENGINEERS & ARCHITECTS	ENGINEERS & ARCHITECTS	ENGINEERS & ARCHITECTS
ALBUQUERQUE, N.M.	ALBUQUERQUE, N.M.	ALBUQUERQUE, N.M.	ALBUQUERQUE, N.M.

CITY OF ALBUQUERQUE		PUBLIC WORKS DEPARTMENT	
SPECIAL ASSESSMENT DISTRICT NO. 218		HANOVER ROAD	
SPECIAL ASSESSMENT DISTRICT NO. 218		HANOVER ROAD	

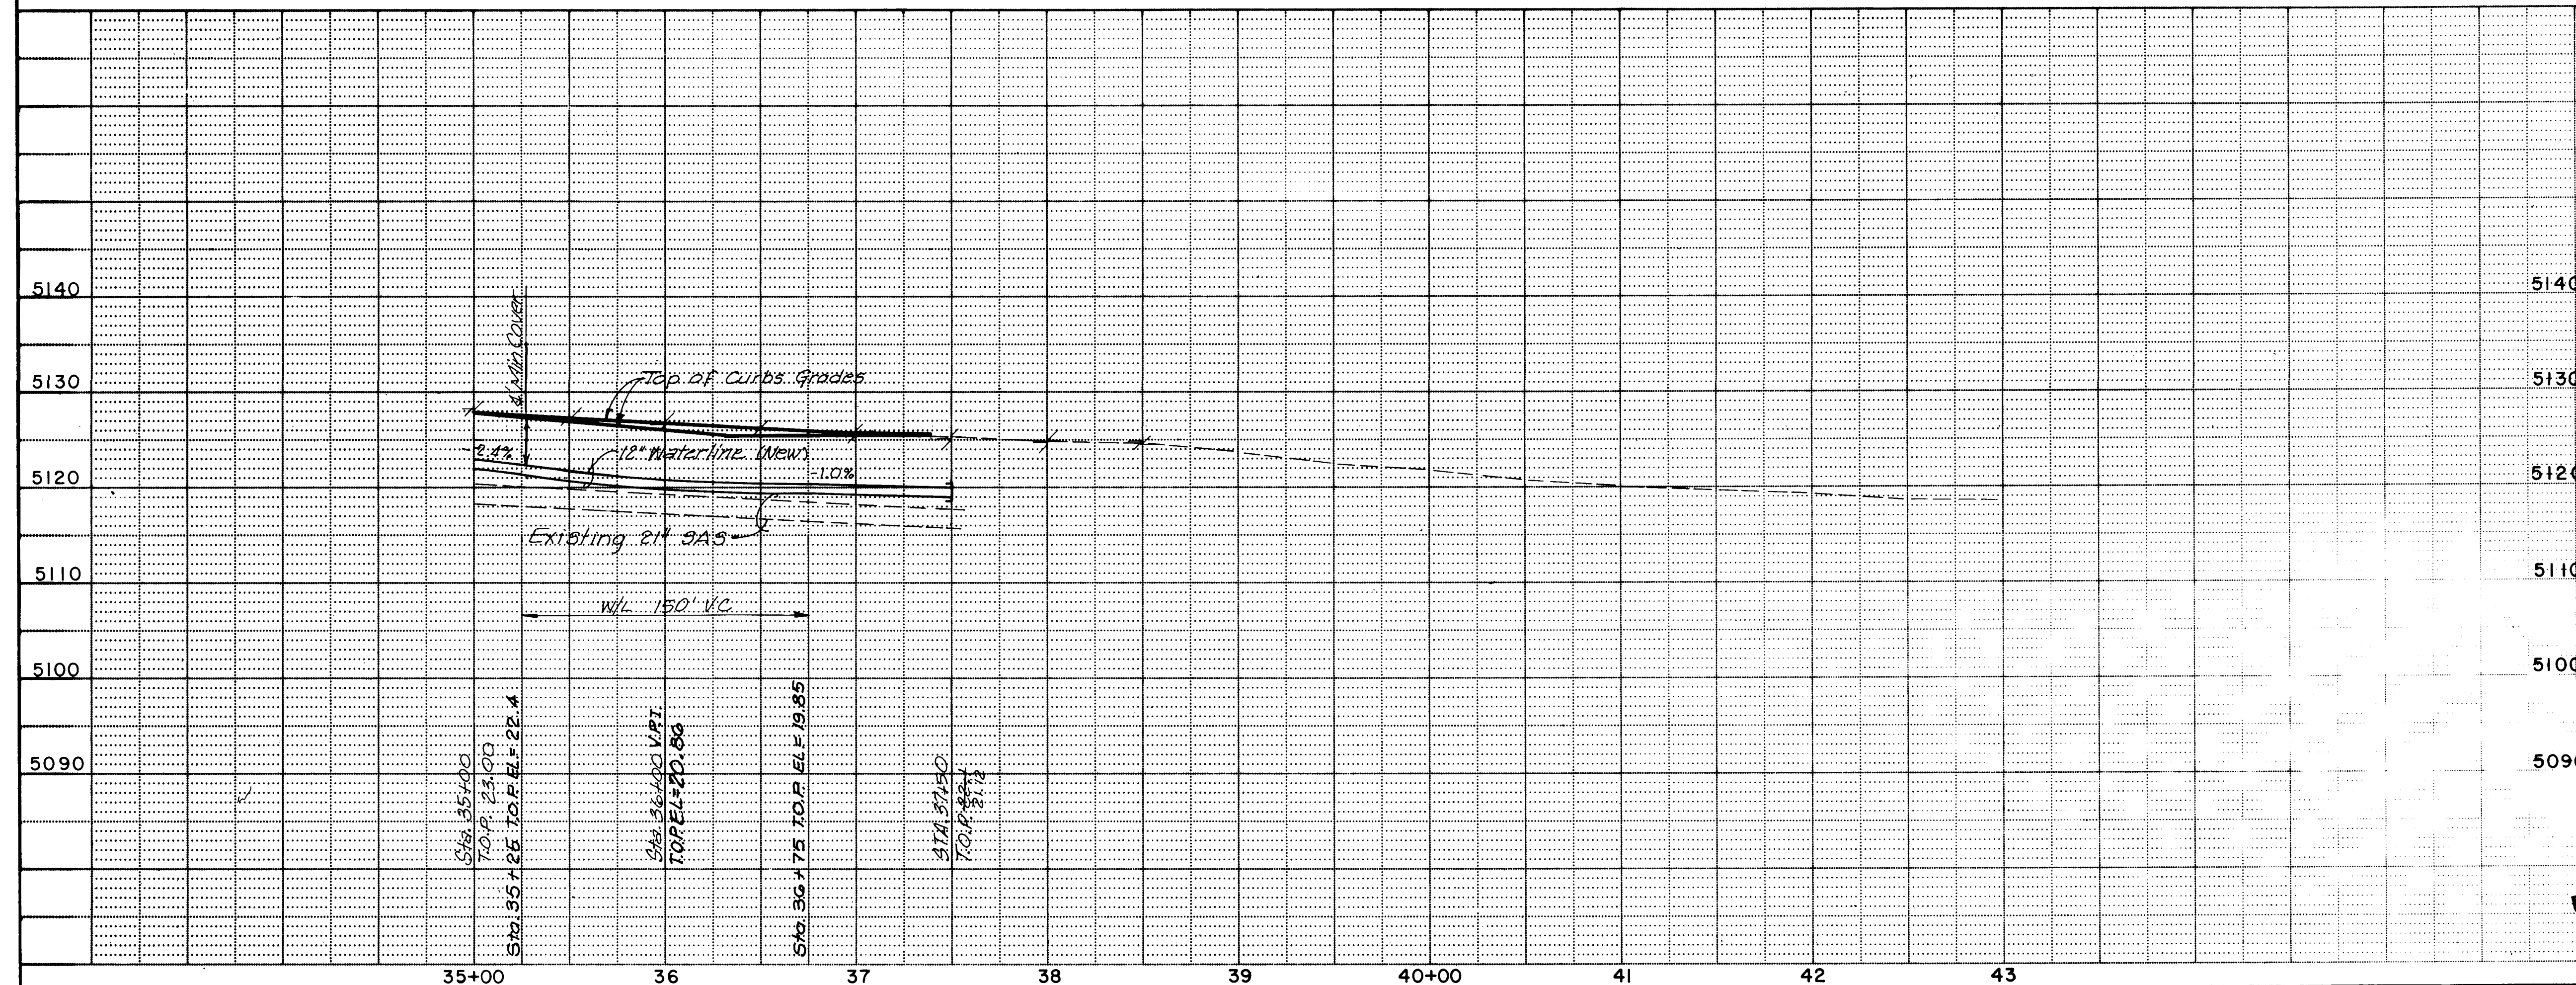


CITY OF ALBUQUERQUE PUBLIC WORKS DEPARTMENT SPECIAL ASSESSMENT DISTRICT NO. 218					
HANOVER ROAD					
APPROVALS	ENGINEER	DATE	APPROVALS	ENGINEER	DATE
City Engineer	<i>Ronald Shaw</i>	3-14-89	Liquid Waste	<i>Red</i>	3/15/89
A-C-E - Design	"	"	Traffic	<i>Ronald Shaw</i>	3-14-89
A-C-E - Hydrology	<i>CAM</i>	NA 3-7-89	Water	<i>H. Shaw</i>	3/10/89
DRAWING NO.	3229		MAP NO. H-10 & J-10	SHEET 12 OF 52	

EL RANCHO ATRISCO PHASE III
HERITAGE PLAZA SUBDIVISION
TRACT I

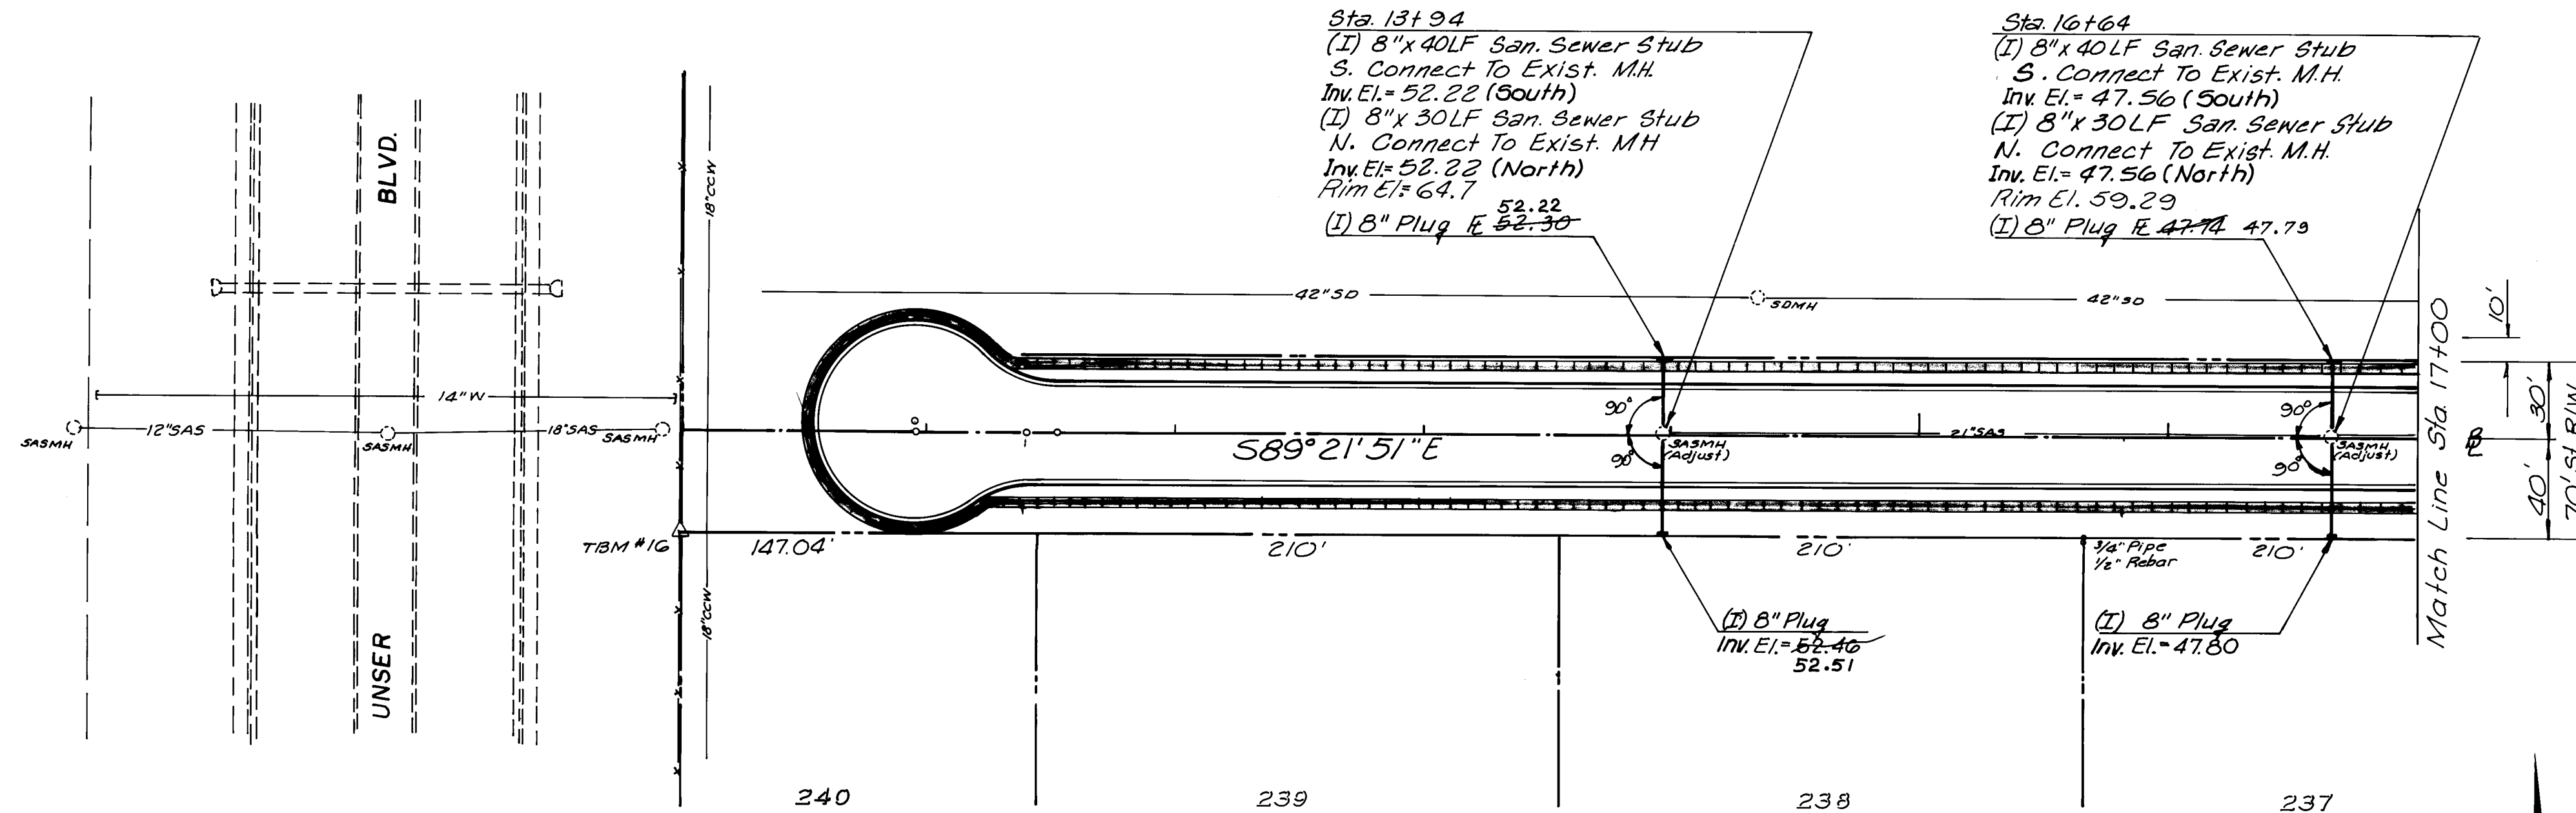

TOWN OF ATRISCO GRANT AIRPORT UNIT

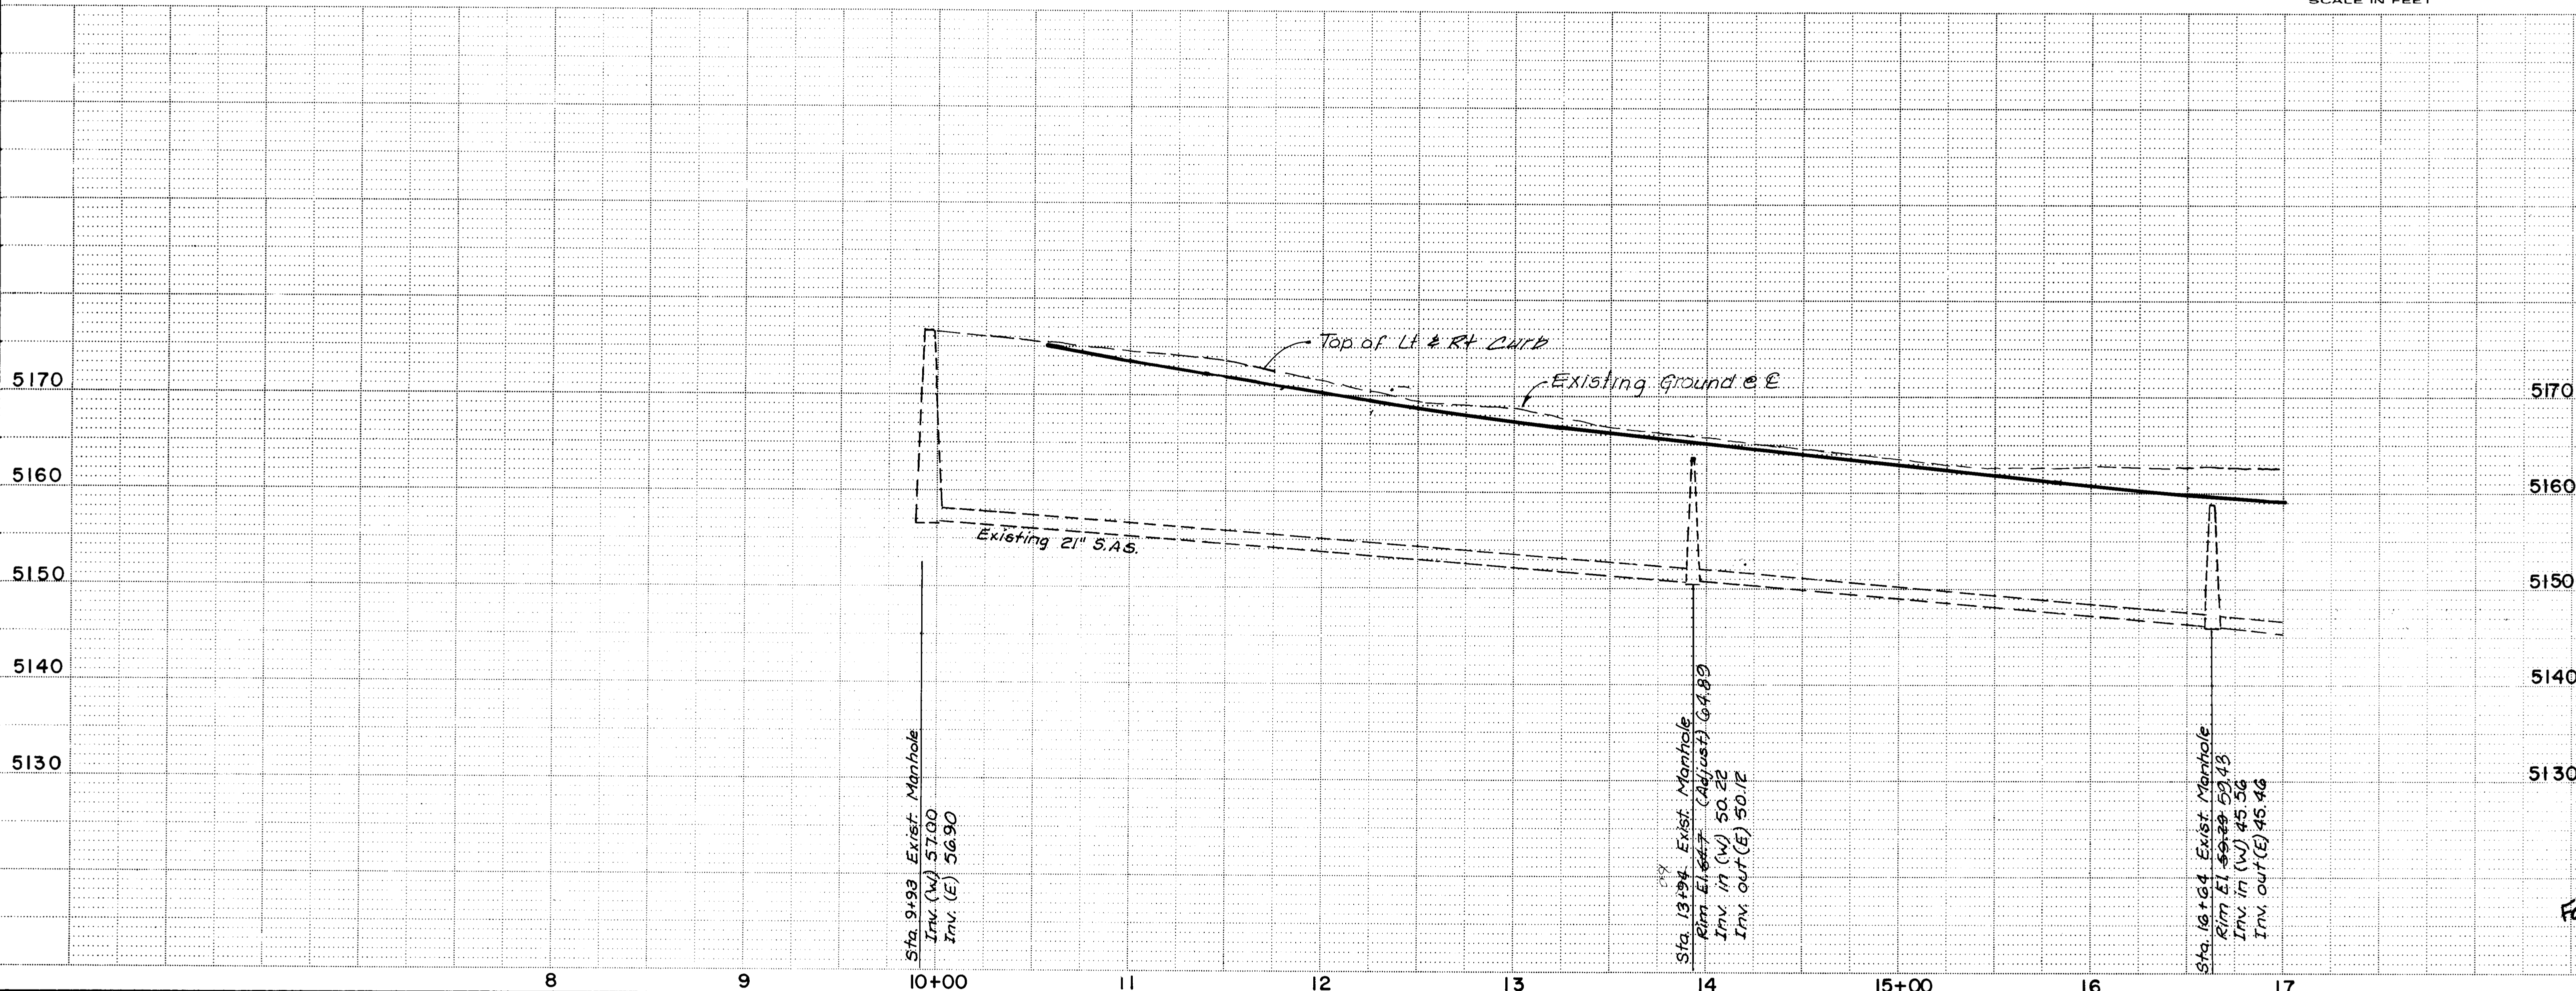

SAN. SEWER

CITY OF ALBUQUERQUE
PUBLIC WORKS DEPARTMENT
SPECIAL ASSESSMENT DISTRICT NO. 218

HANOVER ROAD

APPROVALS	ENGINEER	DATE	APPROVALS	ENGINEER	DATE
City Engineer	Reginald	3-14-89	Liquid Waste	Reginald	3-14-89
City Engineer	Reginald	3-14-89	Traffic	Reginald	3-14-89
City Engineer	Reginald	3-14-89	Water	Reginald	3-14-89

DRAWING NO.	3229	MAP NO.	J-9	SHEET	13	OF	52
-------------	------	---------	-----	-------	----	----	----


RECORD DRAWING
DATE 3-1-90

WILSON & COMPANY
ENGINEERS & ARCHITECTS
ALBUQUERQUE NEW MEXICO


510217

EL RANCHO ATRISCO PHASE III
HERITAGE PLAZA SUBDIVISION
TRACT I

LAURELWOOD SUBDIVISION UNIT 1B

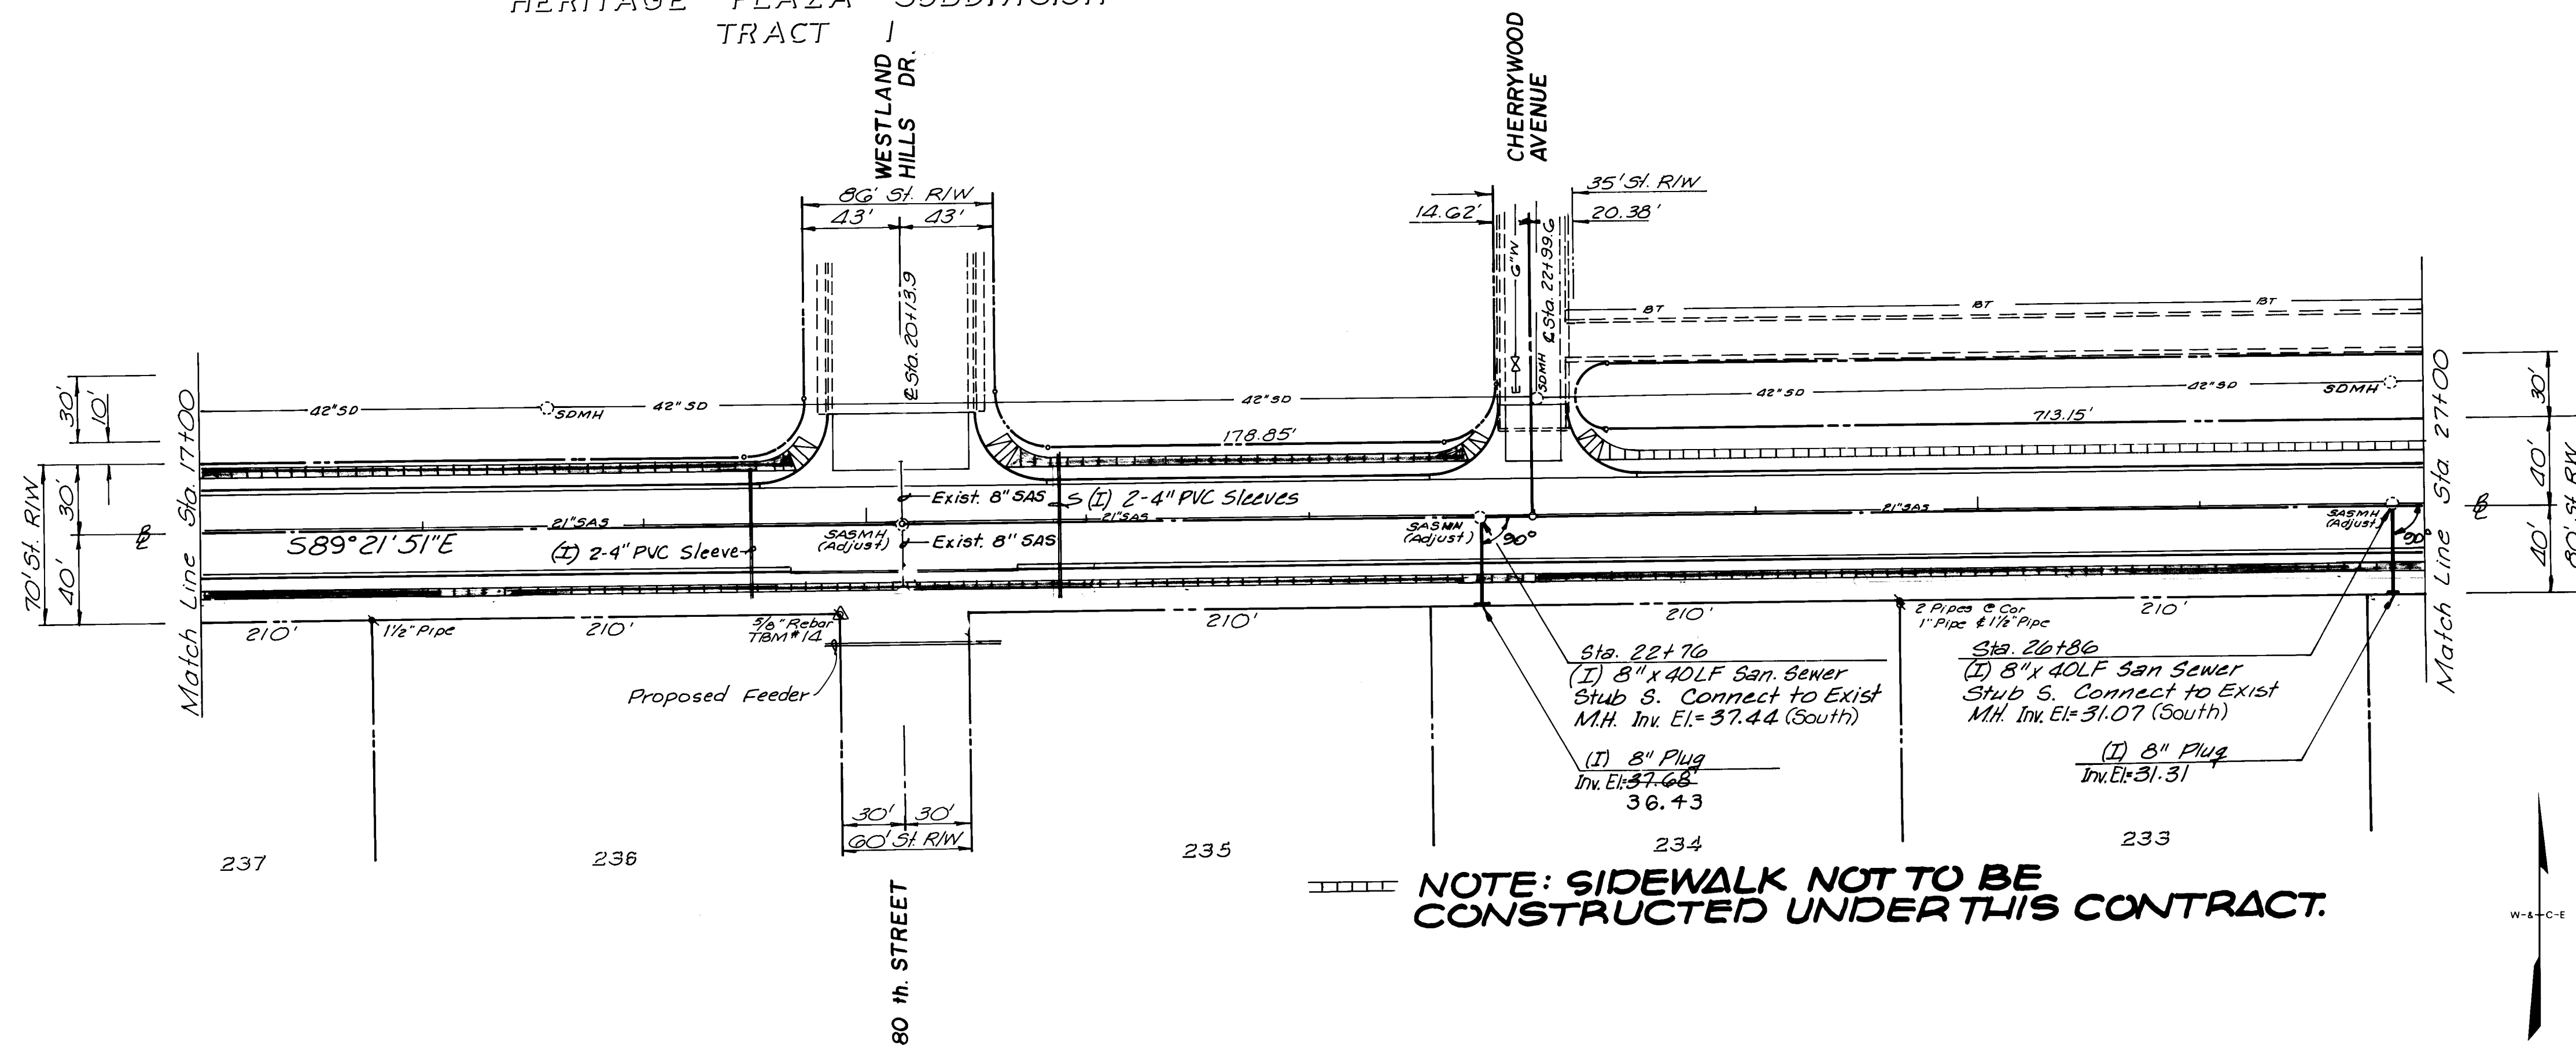

TOWN OF ATRISCO GRANT - AIRPORT UNIT

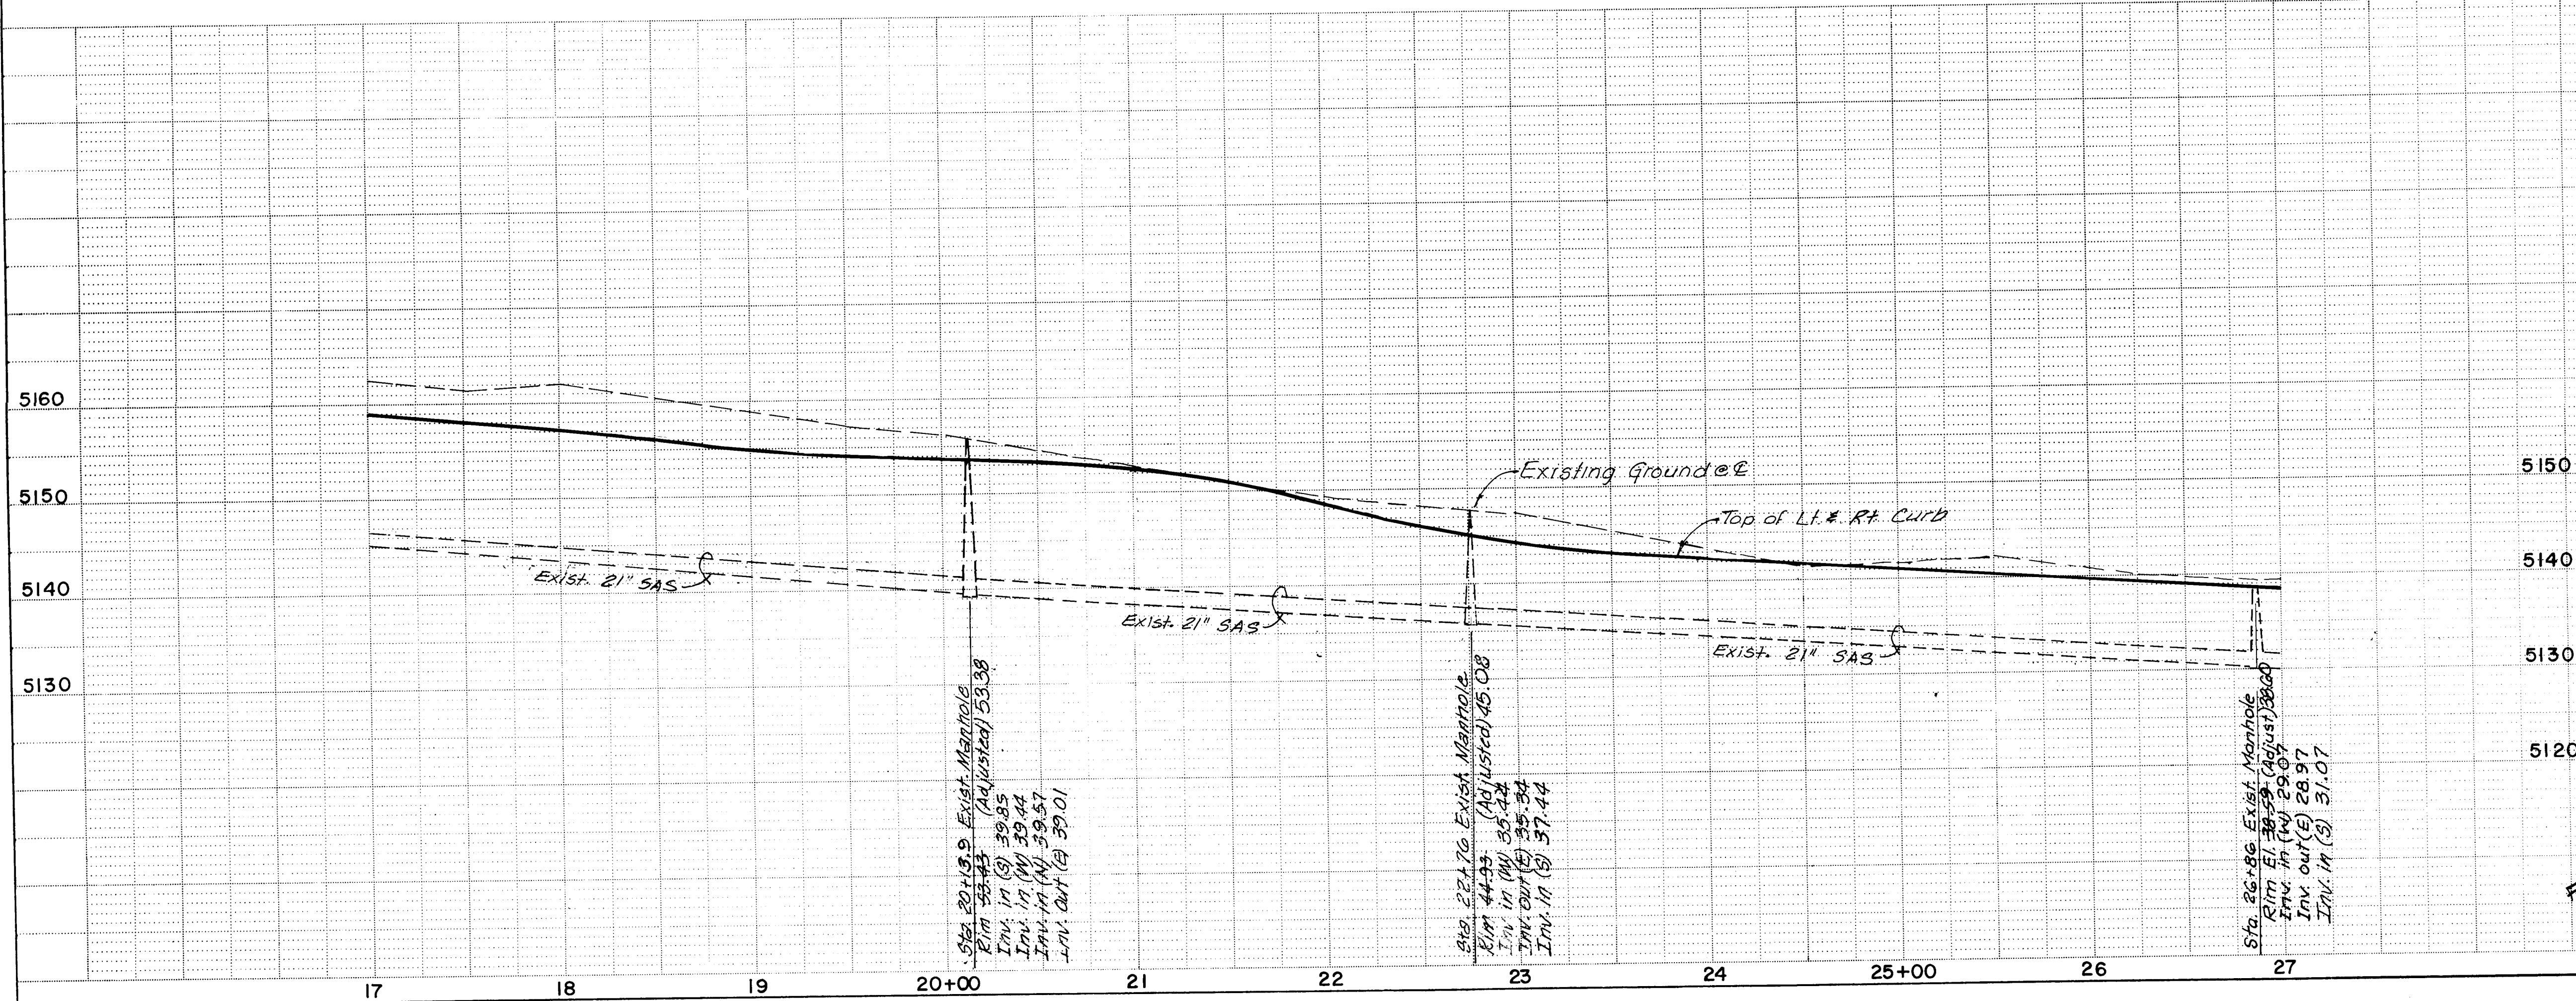

SAN. SEWER

CITY OF ALBUQUERQUE
PUBLIC WORKS DEPARTMENT
SPECIAL ASSESSMENT DISTRICT NO. 218

HANOVER ROAD

APPROVALS	ENGINEER	DATE	APPROVALS	ENGINEER	DATE
City Engineer	Rogel	3-14-89	Liquid Waste	Miner	3/16/89
Design	"	"	Traffic	Rogel	3-14-89
Hydrology	AR	3-7-89	Water	Rogel	3/16/89

DRAWING NO.	3229	MAP NO.	H-10 & J-10	SHEET	14	OF	52
-------------	------	---------	-------------	-------	----	----	----

RECORD DRAWING
Date 3-21-90

WILSON & COMPANY
ENGINEERS & ARCHITECTS
ALBUQUERQUE NEW MEXICO

87-514

AS BUILT INFORMATION	BENCH MARKS	SURVEY INFORMATION	ENGINEER'S SEAL
CONTRACTOR UNIVERSAL CONSTRUCTION	TRM # 14 Sta 19+90 - 20' R/L	FIELD NOTES	
DATE: 6-89	Inspector: R. Hawley	DATE: 2-90	


REVISIONS	NO.	DATE	BY
1	2	2	9
2	2	2	9
3	2	2	9
4	2	2	9
5	2	2	9
6	2	2	9
7	2	2	9
8	2	2	9
9	2	2	9
10	2	2	9
11	2	2	9
12	2	2	9

REMARKS	NO.	DATE	BY
1	2	2	9
2	2	2	9
3	2	2	9
4	2	2	9
5	2	2	9
6	2	2	9
7	2	2	9
8	2	2	9
9	2	2	9
10	2	2	9
11	2	2	9
12	2	2	9

REVISIONS	NO.	DATE	BY
1	2	2	9
2	2	2	9
3	2	2	9
4	2	2	9
5	2	2	9
6	2	2	9
7	2	2	9
8	2	2	9
9	2	2	9
10	2	2	9
11	2	2	9
12	2	2	9



REVISIONS	NO.	DATE	BY
1	2	2	9
2	2	2	9
3	2	2	9
4	2	2	9
5	2	2	9
6	2	2	9
7	2	2	9
8	2	2	9
9	2	2	9
10	2	2	9
11	2	2	9
12	2	2	9

PARK & DRAINAGE
MANAGEMENT AREA

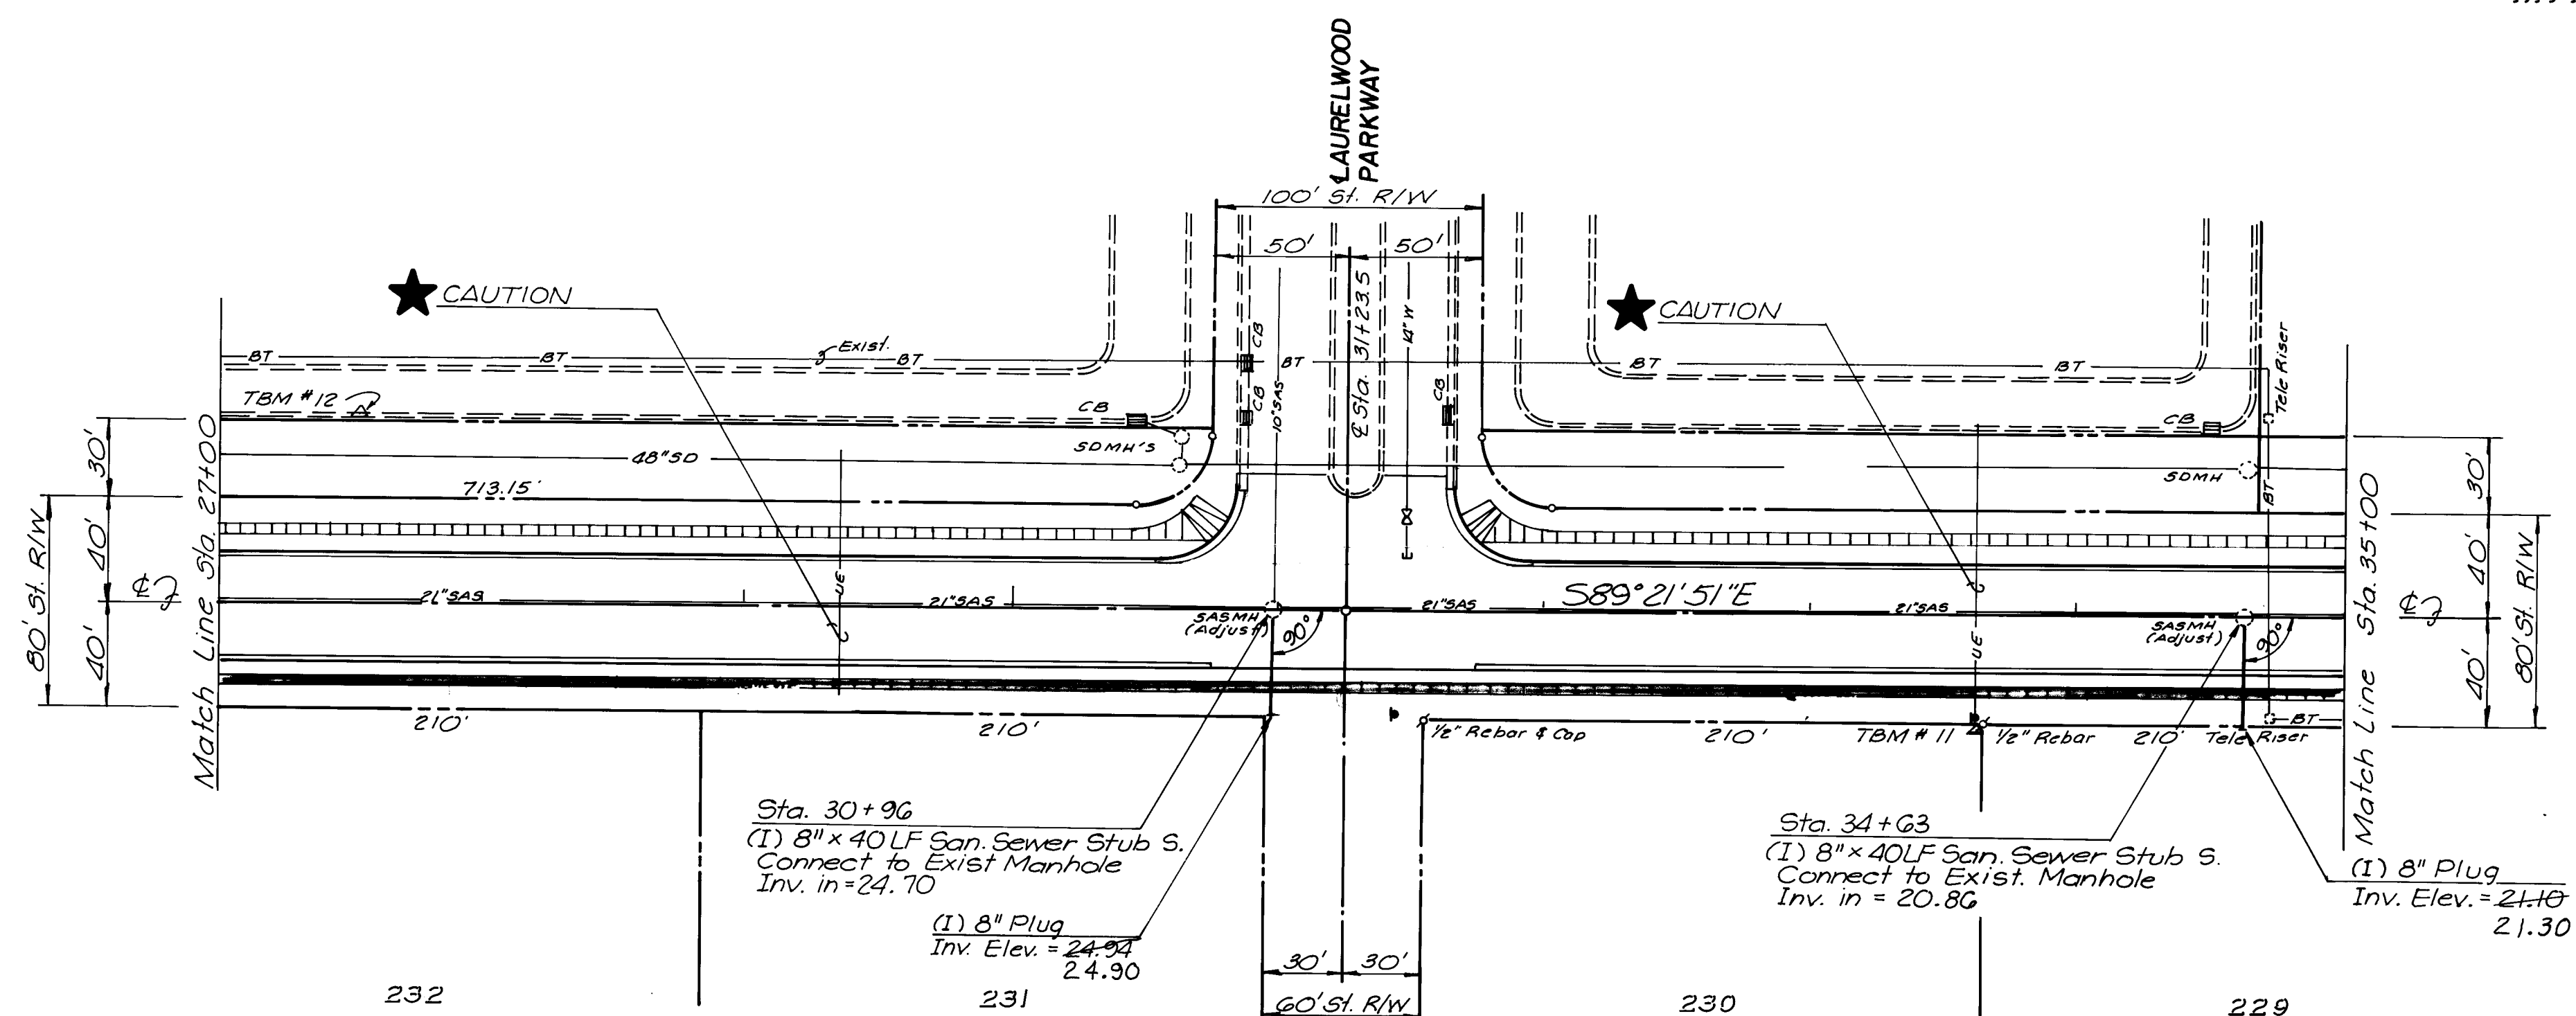

**NOTE: SIDEWALK IS NOT TO BE
CONSTRUCTED UNDER THIS CONTRACT.**

TOWN OF ATRISCO GRANT AIRPORT UNIT

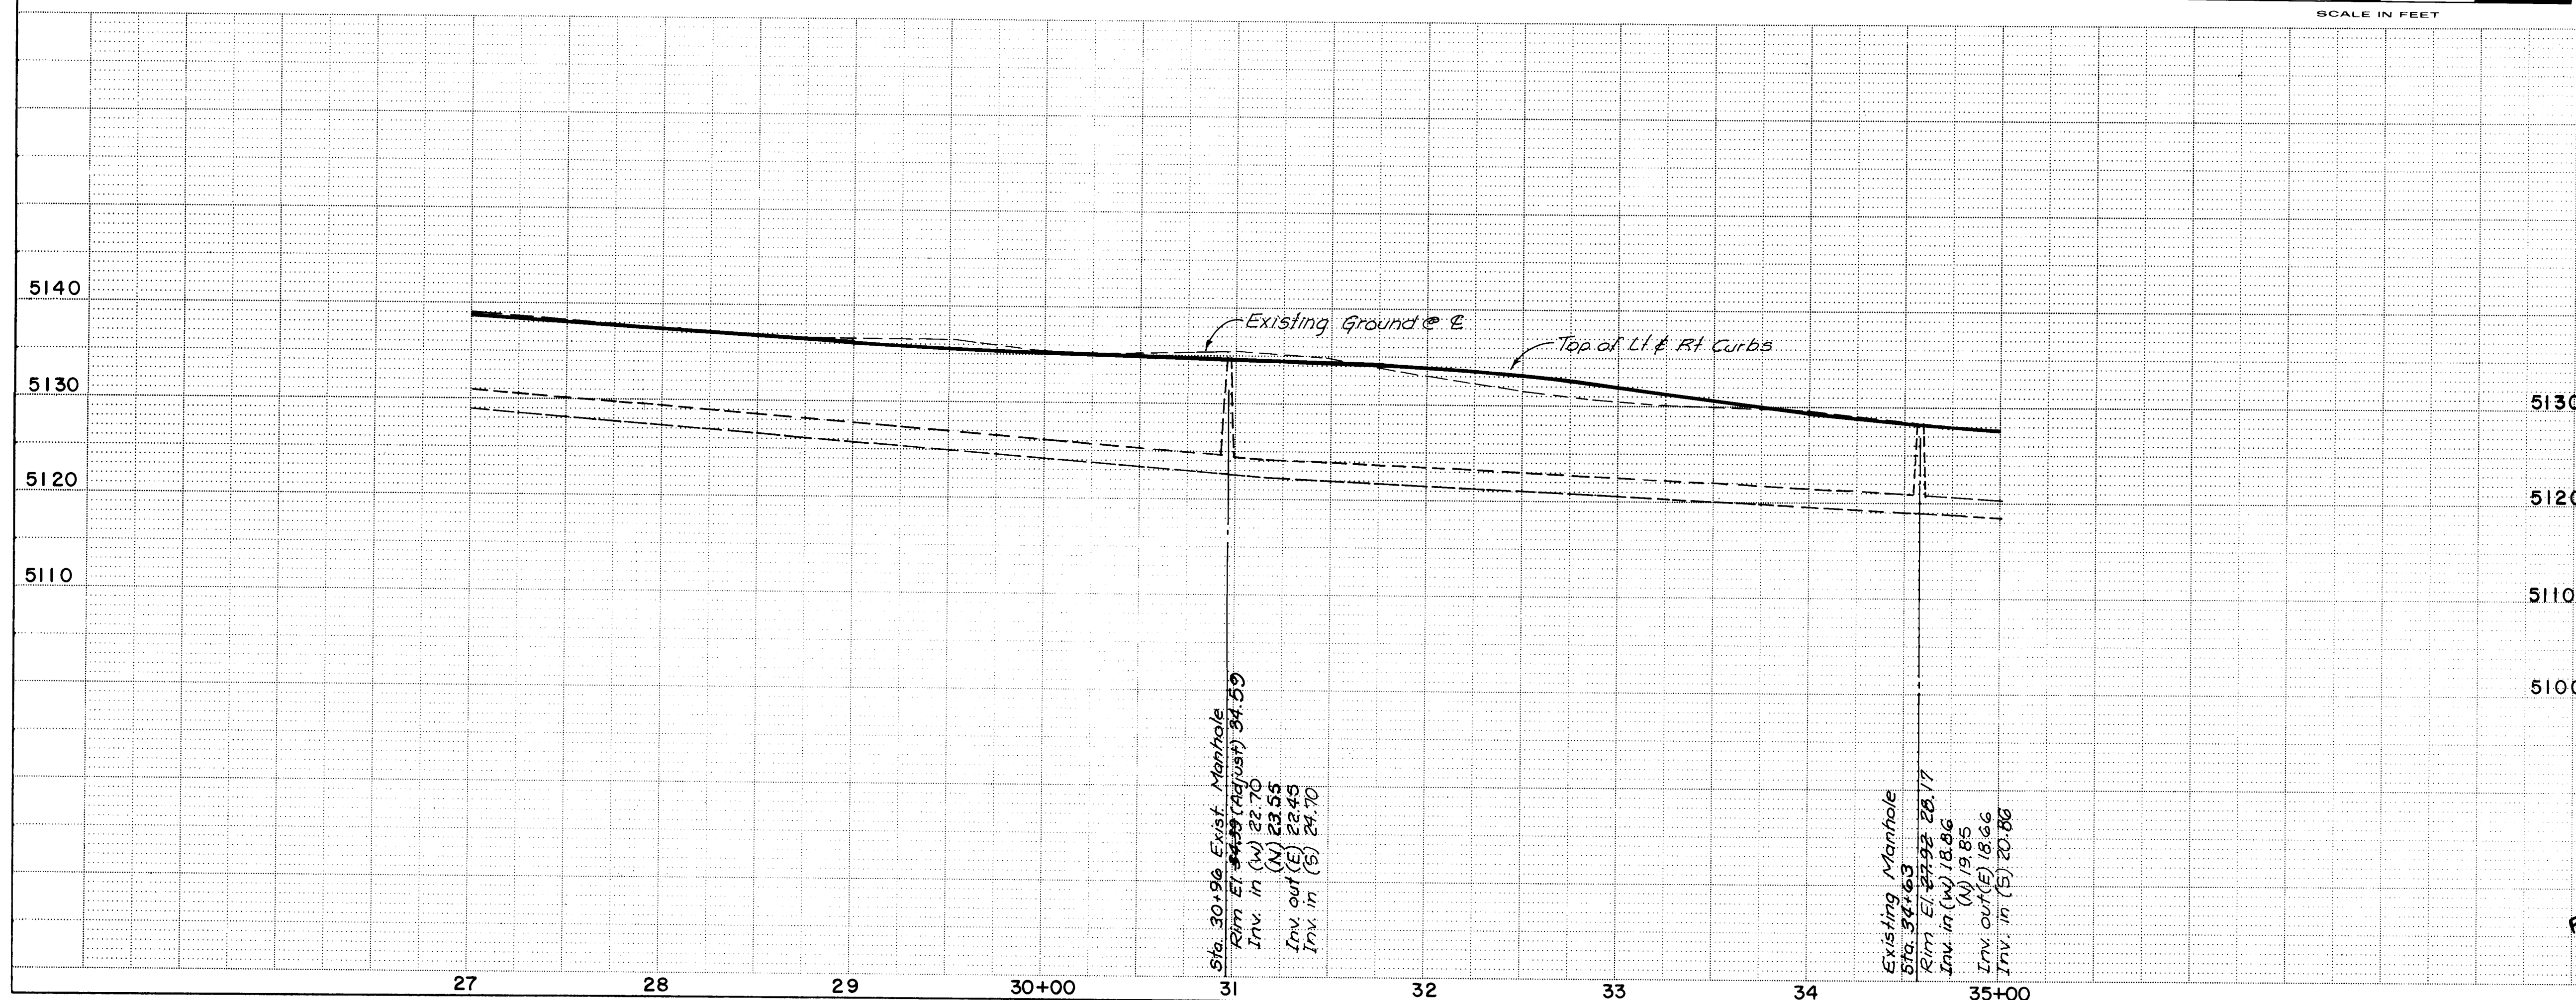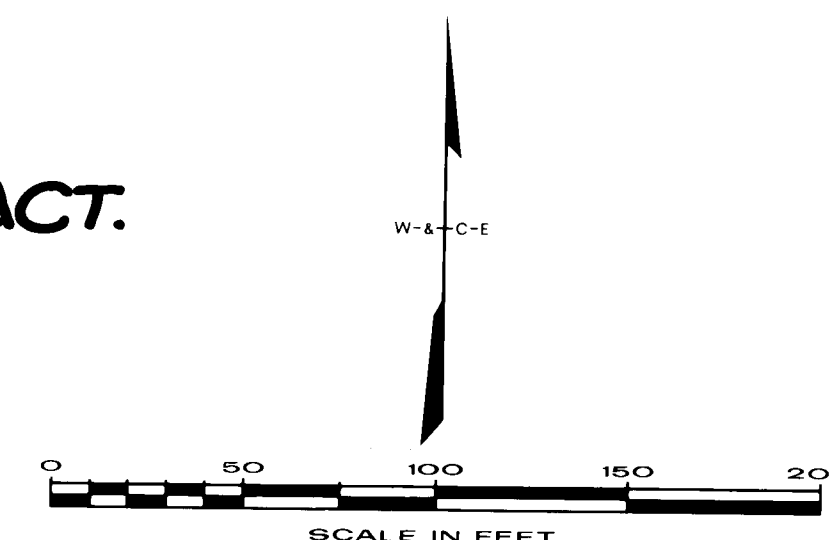

SAN. SEWER

CITY OF ALBUQUERQUE
PUBLIC WORKS DEPARTMENT
SPECIAL ASSESSMENT DISTRICT NO. 218

HANOVER ROAD

APPROVALS	ENGINEER	DATE	APPROVALS	ENGINEER	DATE
City Engineer	Roger L. Brown	3-14-89	Liquid Waste	Michael J. Brown	3/6/89
ACE - Design	"	"	Traffic	Roger L. Brown	3-14-89
ACE - Hydrology	CAM NA	3-7-89	Water	ACE	3/6/89

DRAWING NO.	3229	MAP NO. H · 10 & J · 10	SHEET 15 OF 52
-------------	-------------	----------------------------	------------------------------


RECORD DRAWING
DATE 8-1-90

WILSON & COMPANY
ENGINEERS & ARCHITECTS
ALBUQUERQUE NEW MEXICO



87-514

[illegible]

TOWN OF ATRISCO GRANT - UNIT NO. EIGHT

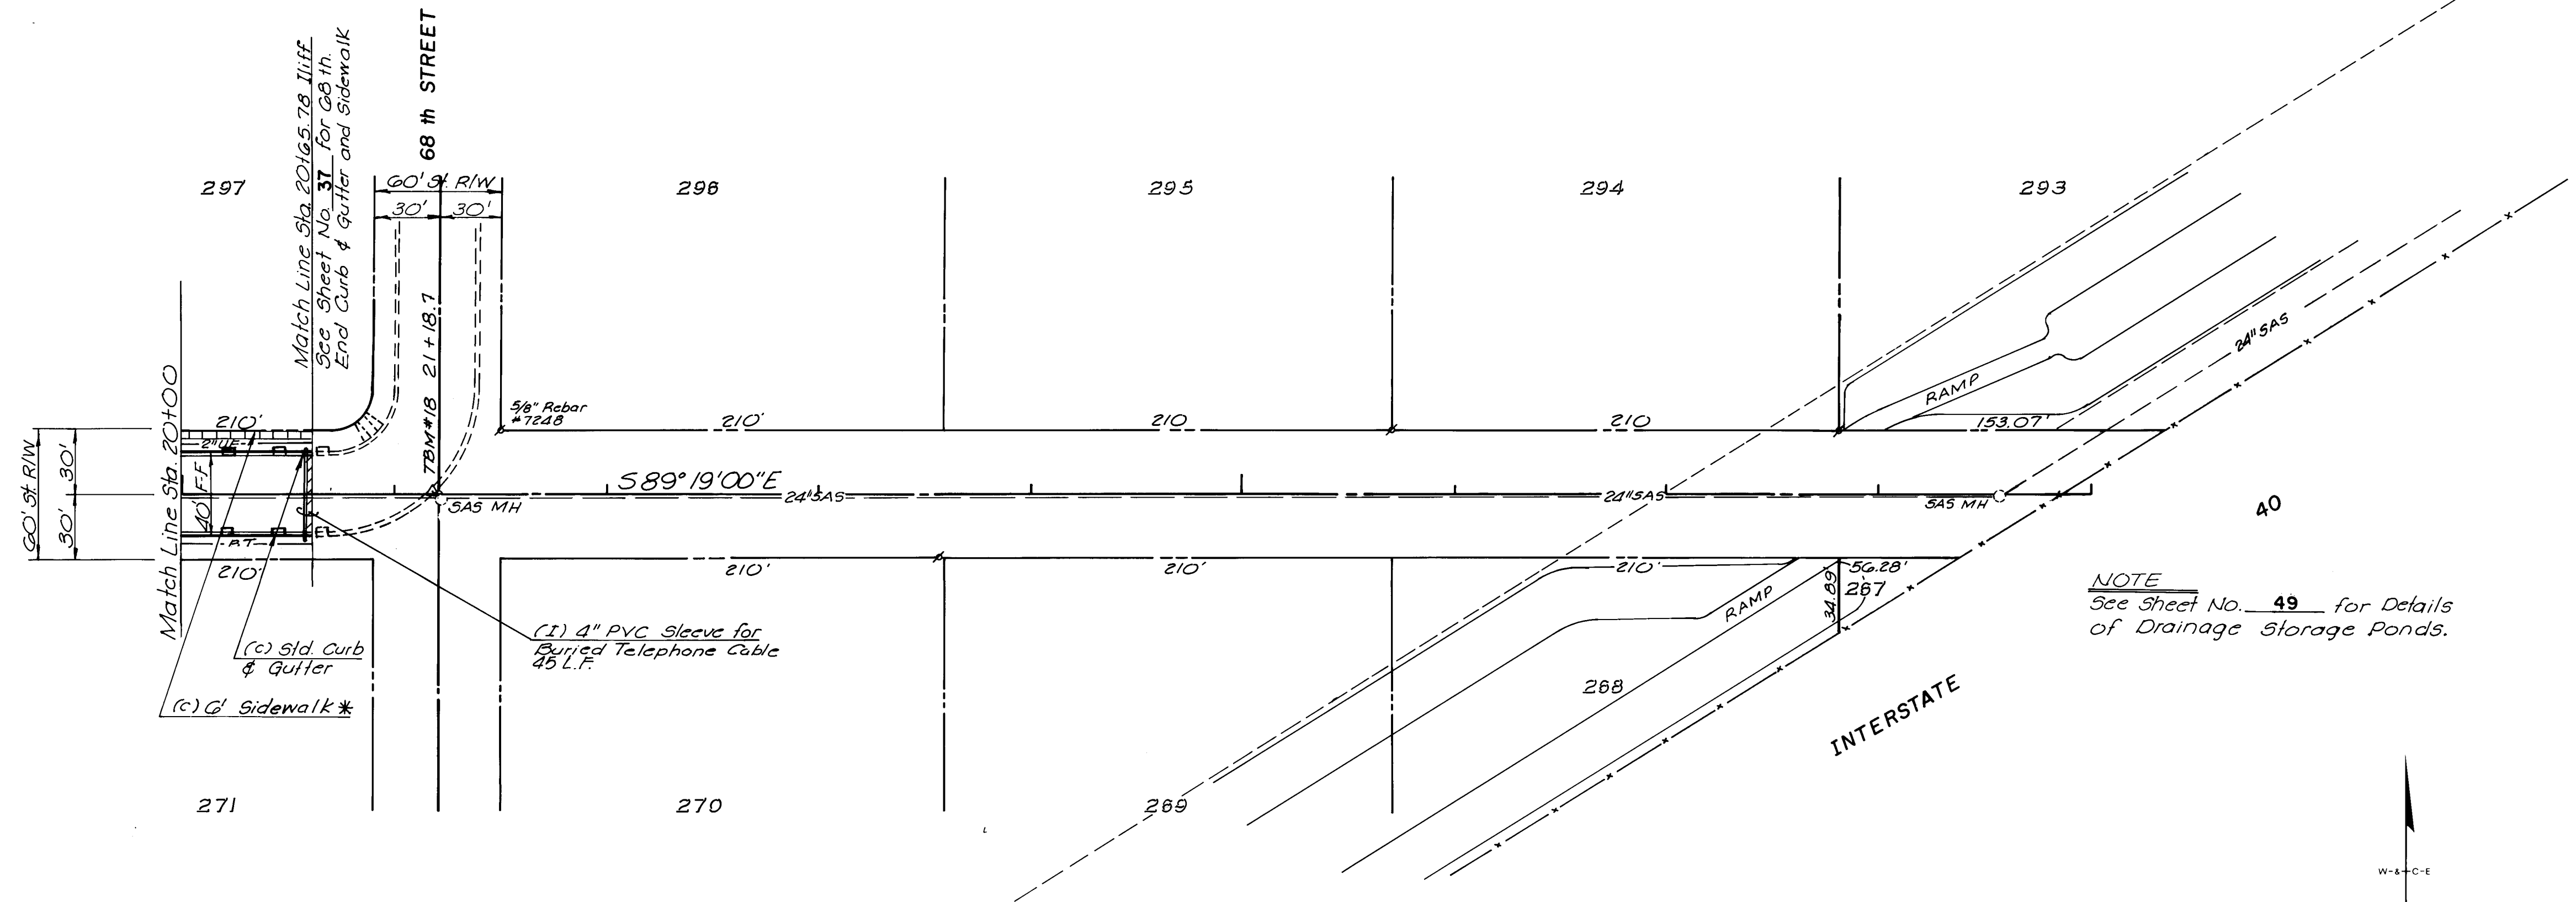

NOTE
See Sheet No. 49 for Details
of Drainage Storage Ponds.

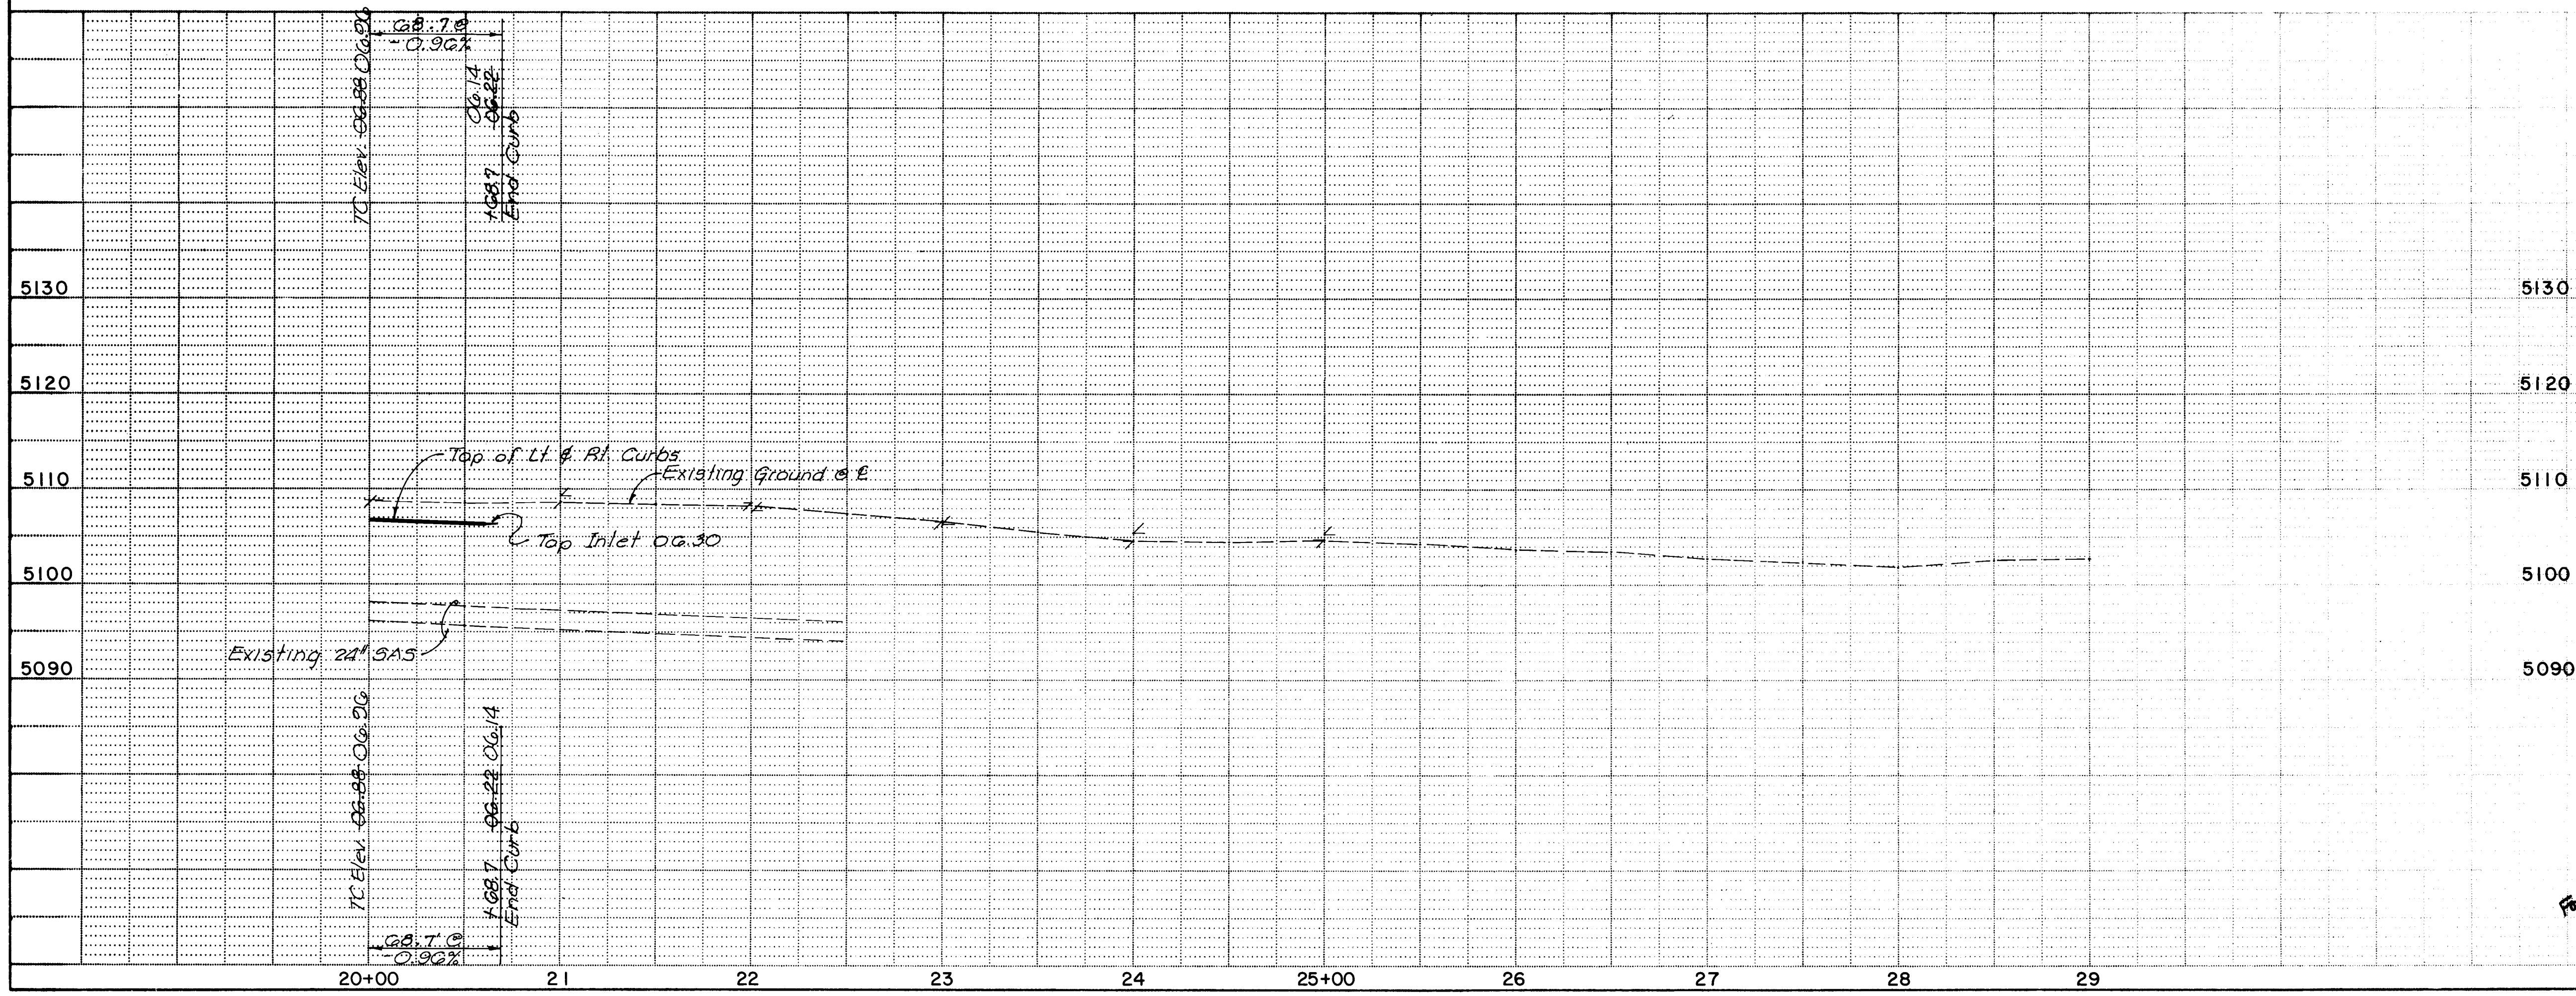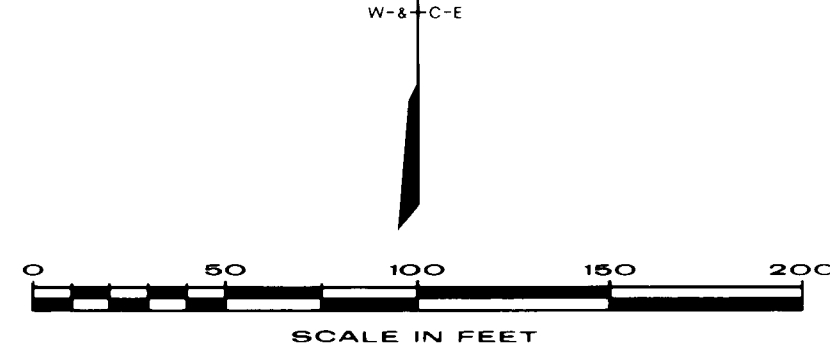

1 2 3 4 5 6 7 8 9 10 11 12
26 32 29 17 9 0

PAVING

CITY OF ALBUQUERQUE
PUBLIC WORKS DEPARTMENT
SPECIAL ASSESSMENT DISTRICT NO. 218

ILIFF ROAD


APPROVALS	ENGINEER	DATE	APPROVALS	ENGINEER	DATE
City Engineer	Reginald	3-14-89	Liquid Waste	1850	3/6/89
Design	"	"	Traffic	Reginald	3-14-89
Hydrology	ARM	3-7-89	Water	1850	3/6/89

DRAWING NO.	3229	MAP NO.	H-10 & J-10	SHEET	17	OF	52
-------------	------	---------	-------------	-------	----	----	----


RECORD DRAWING
DATE 3-1-90

AS BUILT INFORMATION		BENCH MARKS		UNIVERSAL CONSTRUCTION	
DATE	DATE	DATE	DATE	DATE	DATE
TBM #18 - Sta 21+22 - 2.2' Rt. E	TBM #18 - Sta 21+22 - 2.2' Rt. E	TBM #18 - Sta 21+22 - 2.2' Rt. E	TBM #18 - Sta 21+22 - 2.2' Rt. E	TBM #18 - Sta 21+22 - 2.2' Rt. E	TBM #18 - Sta 21+22 - 2.2' Rt. E
Iliff Road - a Cut NW Corner	Iliff Road - a Cut NW Corner	Iliff Road - a Cut NW Corner	Iliff Road - a Cut NW Corner	Iliff Road - a Cut NW Corner	Iliff Road - a Cut NW Corner
Manhole Rod	Manhole Rod	Manhole Rod	Manhole Rod	Manhole Rod	Manhole Rod
Elevation 5109.43	Elevation 5109.43	Elevation 5109.43	Elevation 5109.43	Elevation 5109.43	Elevation 5109.43

REMARKS		BY	
NO. DATE	REMARKS	NO. DATE	REMARKS
1 2 3 4 5 6 7 8 9 10 11 12	26 32 29 17 9 0	1 2 3 4 5 6 7 8 9 10 11 12	26 32 29 17 9 0

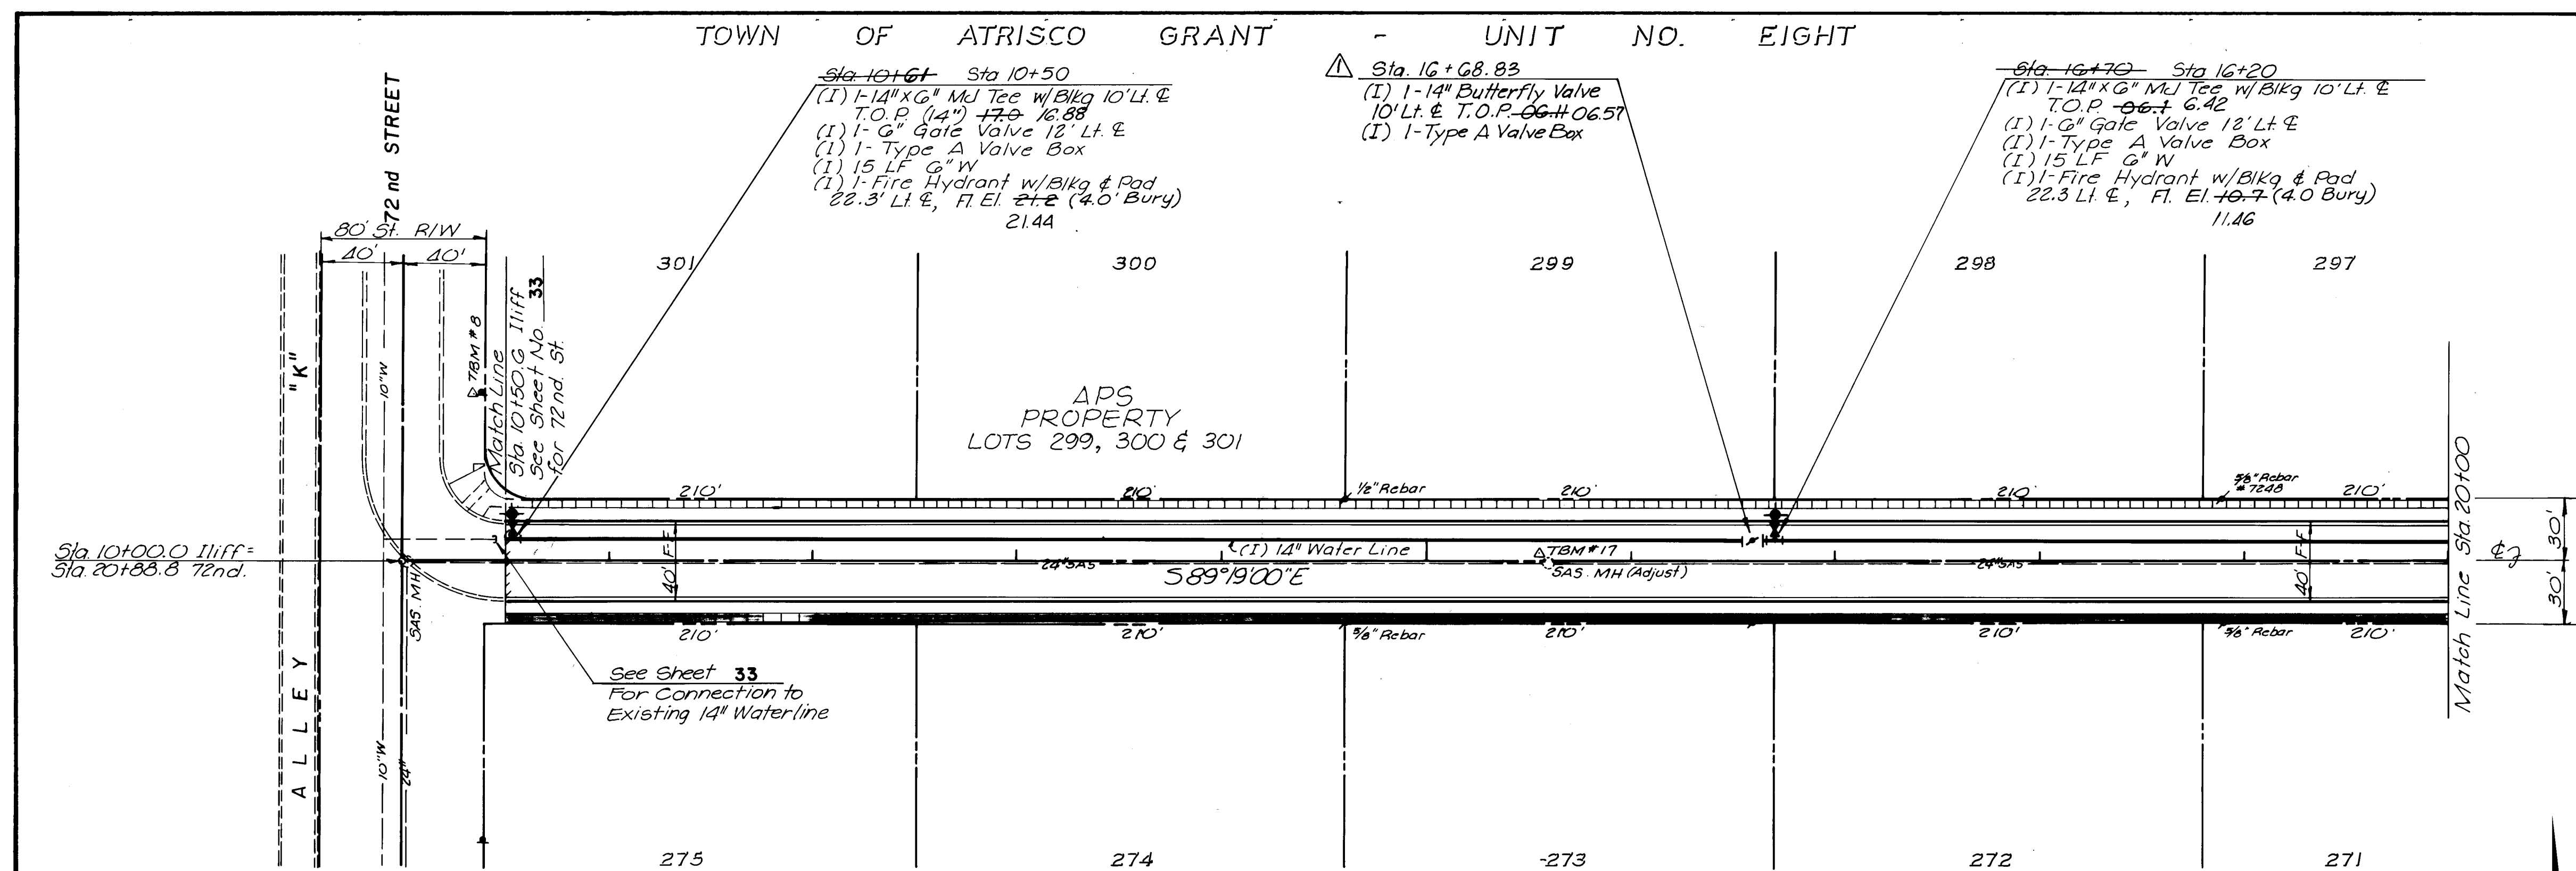

NOTE: SEE SHEET 17 FOR CURB CUTS.

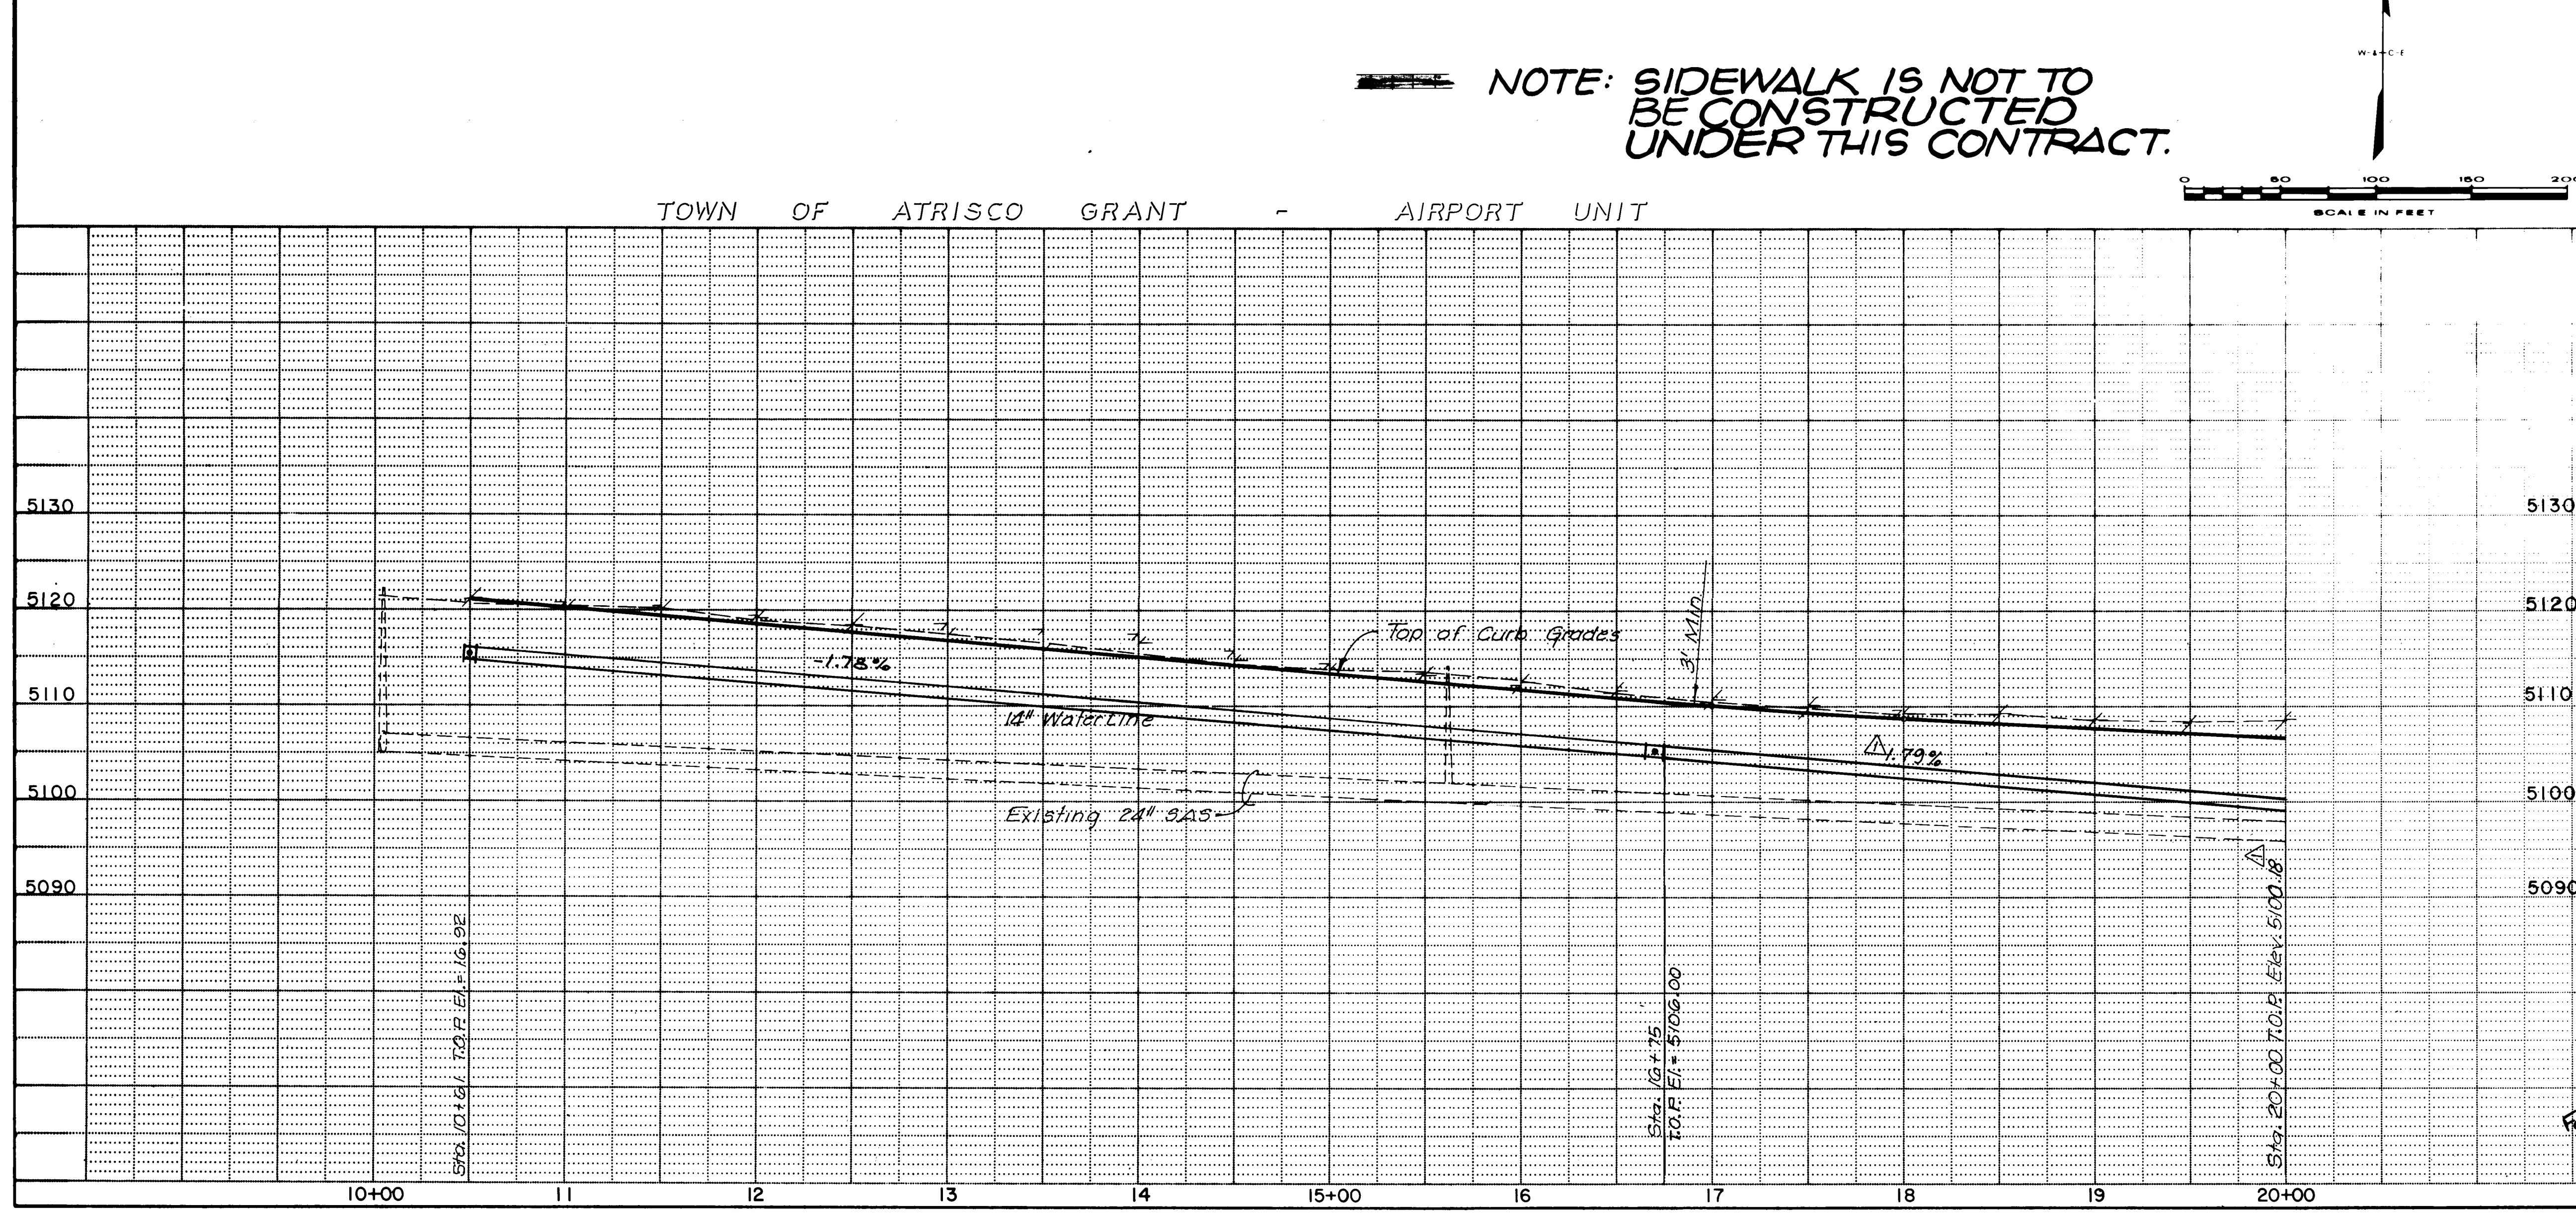

1 2 3 4 5 6 7 8 9 10 11 12
26 32 29 18 9 0

WATER

CITY OF ALBUQUERQUE
PUBLIC WORKS DEPARTMENT
SPECIAL ASSESSMENT DISTRICT NO. 218


ILIFF ROAD

APPROVALS	ENGINEER	DATE	APPROVALS	ENGINEER	DATE
City Engineer	Rogel Shum	3-1-89	Liquid Waste	Rogel Shum	3-16-89
AGE - Design	"	"	Traffic	Rogel Shum	3-16-89
AGE - Hydrology	CAM	3-1-89	Water	Rogel Shum	3-16-89


DRAWING NO. **3229** MAP NO. H-10 & J-10 SHEET **18** OF **52**

RECORD DRAWING
DATE 3-1-90

AS BUILT INFORMATION		BENCH MARKS		SURVEY INFORMATION		ENGINEER'S SEAL	
CONTRACTOR	UNIVERSAL CONSTRUCTION	TBM #8 - Sta. 21+73.3 - 38.5' R/L	Elevation	FIELD NOTES	DATE		REVISIONS
WORKED BY	GVA	72nd Street - RR Spikes in P. Pole		BY			
INSPECTED BY	R. HAMLEY			NO.	DATE		
DATE	2-90						
VERIFICATION BY		TBM #17 - Sta. 15+22.0 - 2' R/L		DESIGNED BY		WILSON & COMPANY, ENGINEERS & ARCHITECTS	
DATE		DATE 12-89		DRAWN BY		DATE	
MICRO-FILM INFORMATION		Manhole Pad		CHECKED BY		DATE	
RECORDED BY		Elevation 5114.22					
NO.							

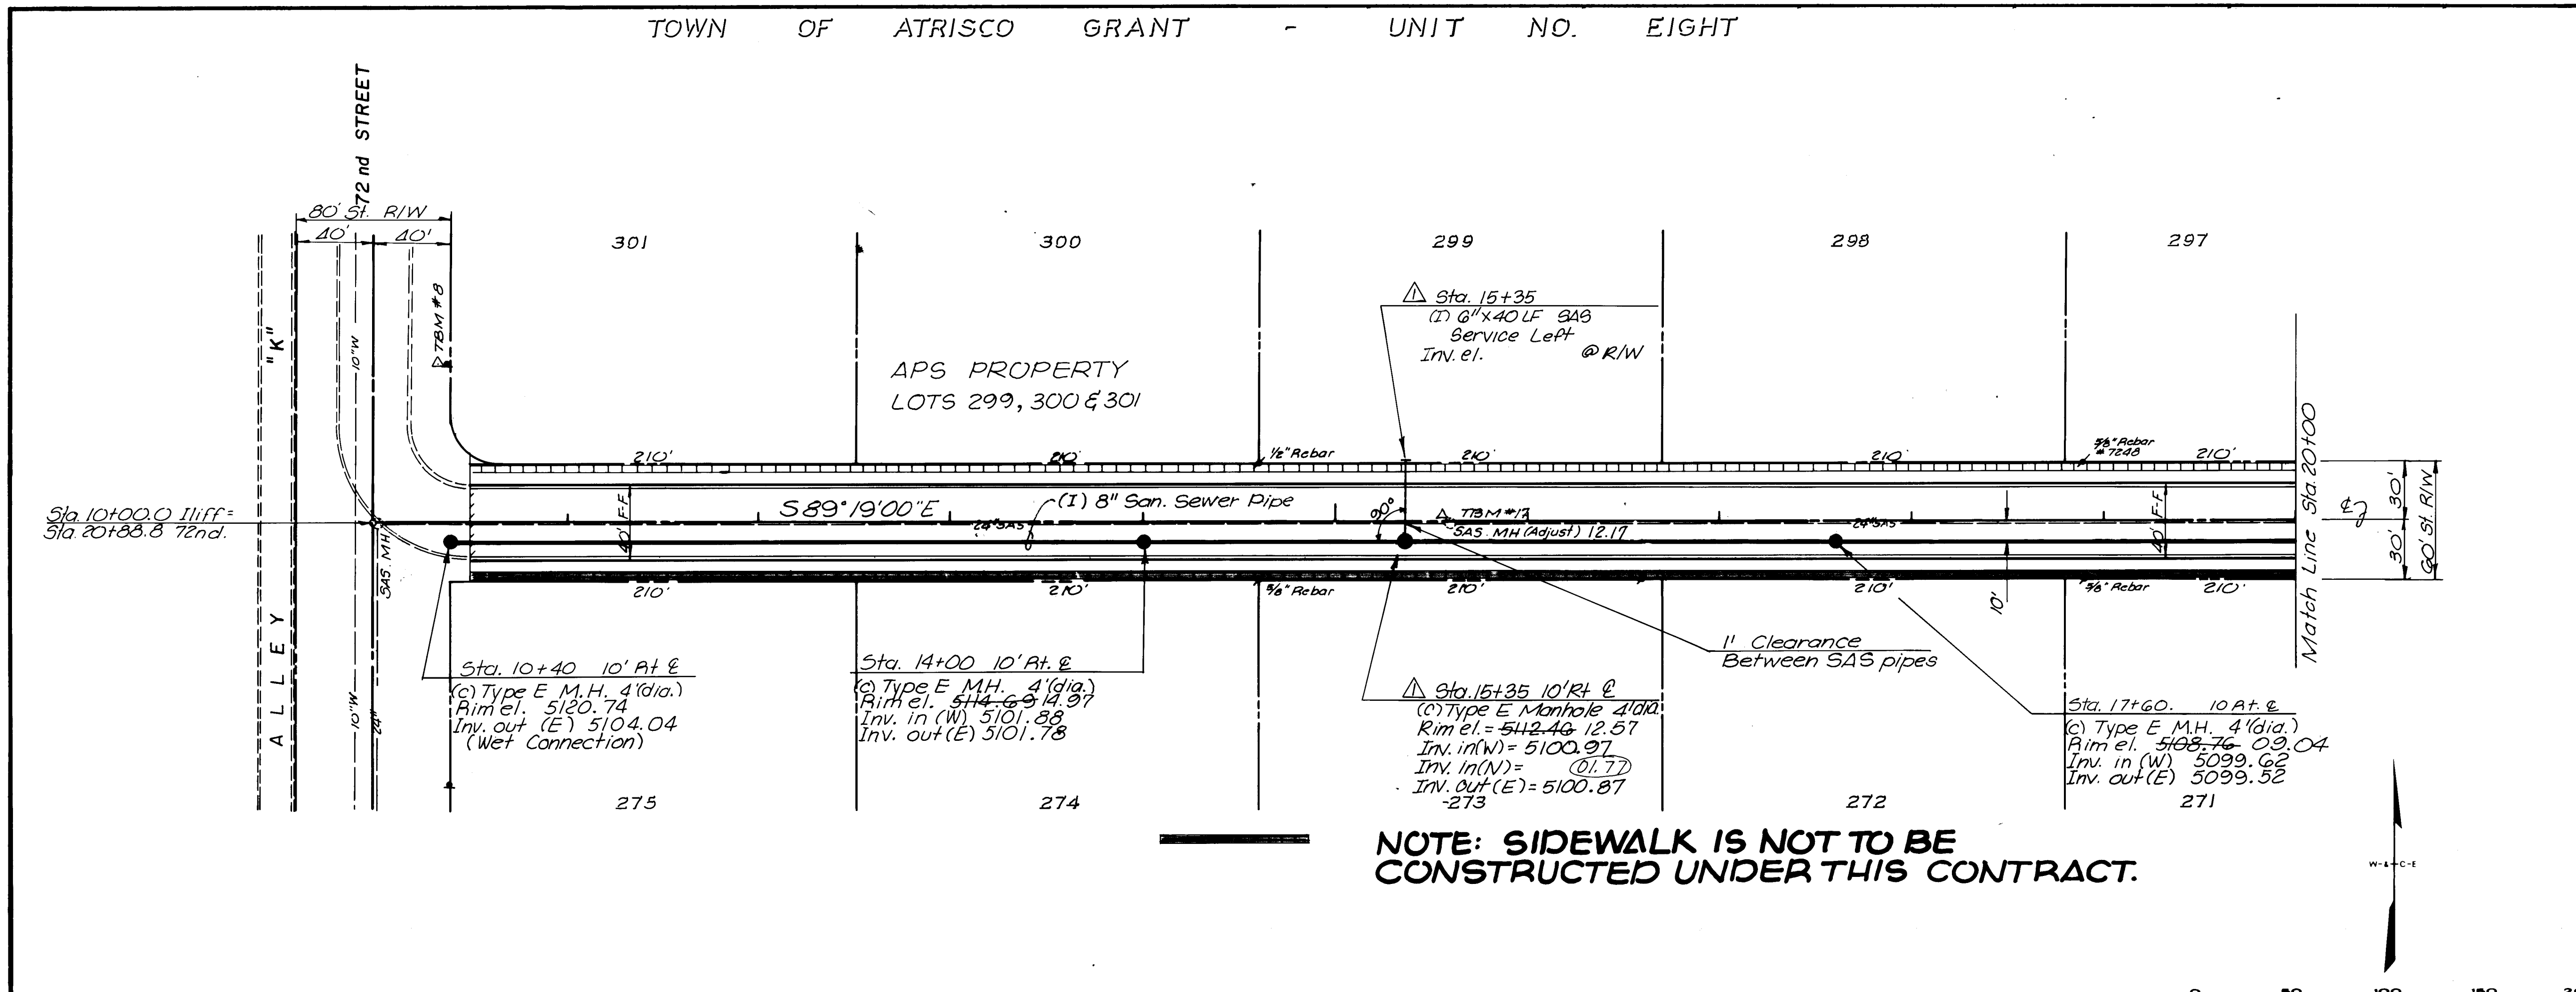

NOTE: SIDEWALK IS NOT TO BE
CONSTRUCTED UNDER THIS CONTRACT.

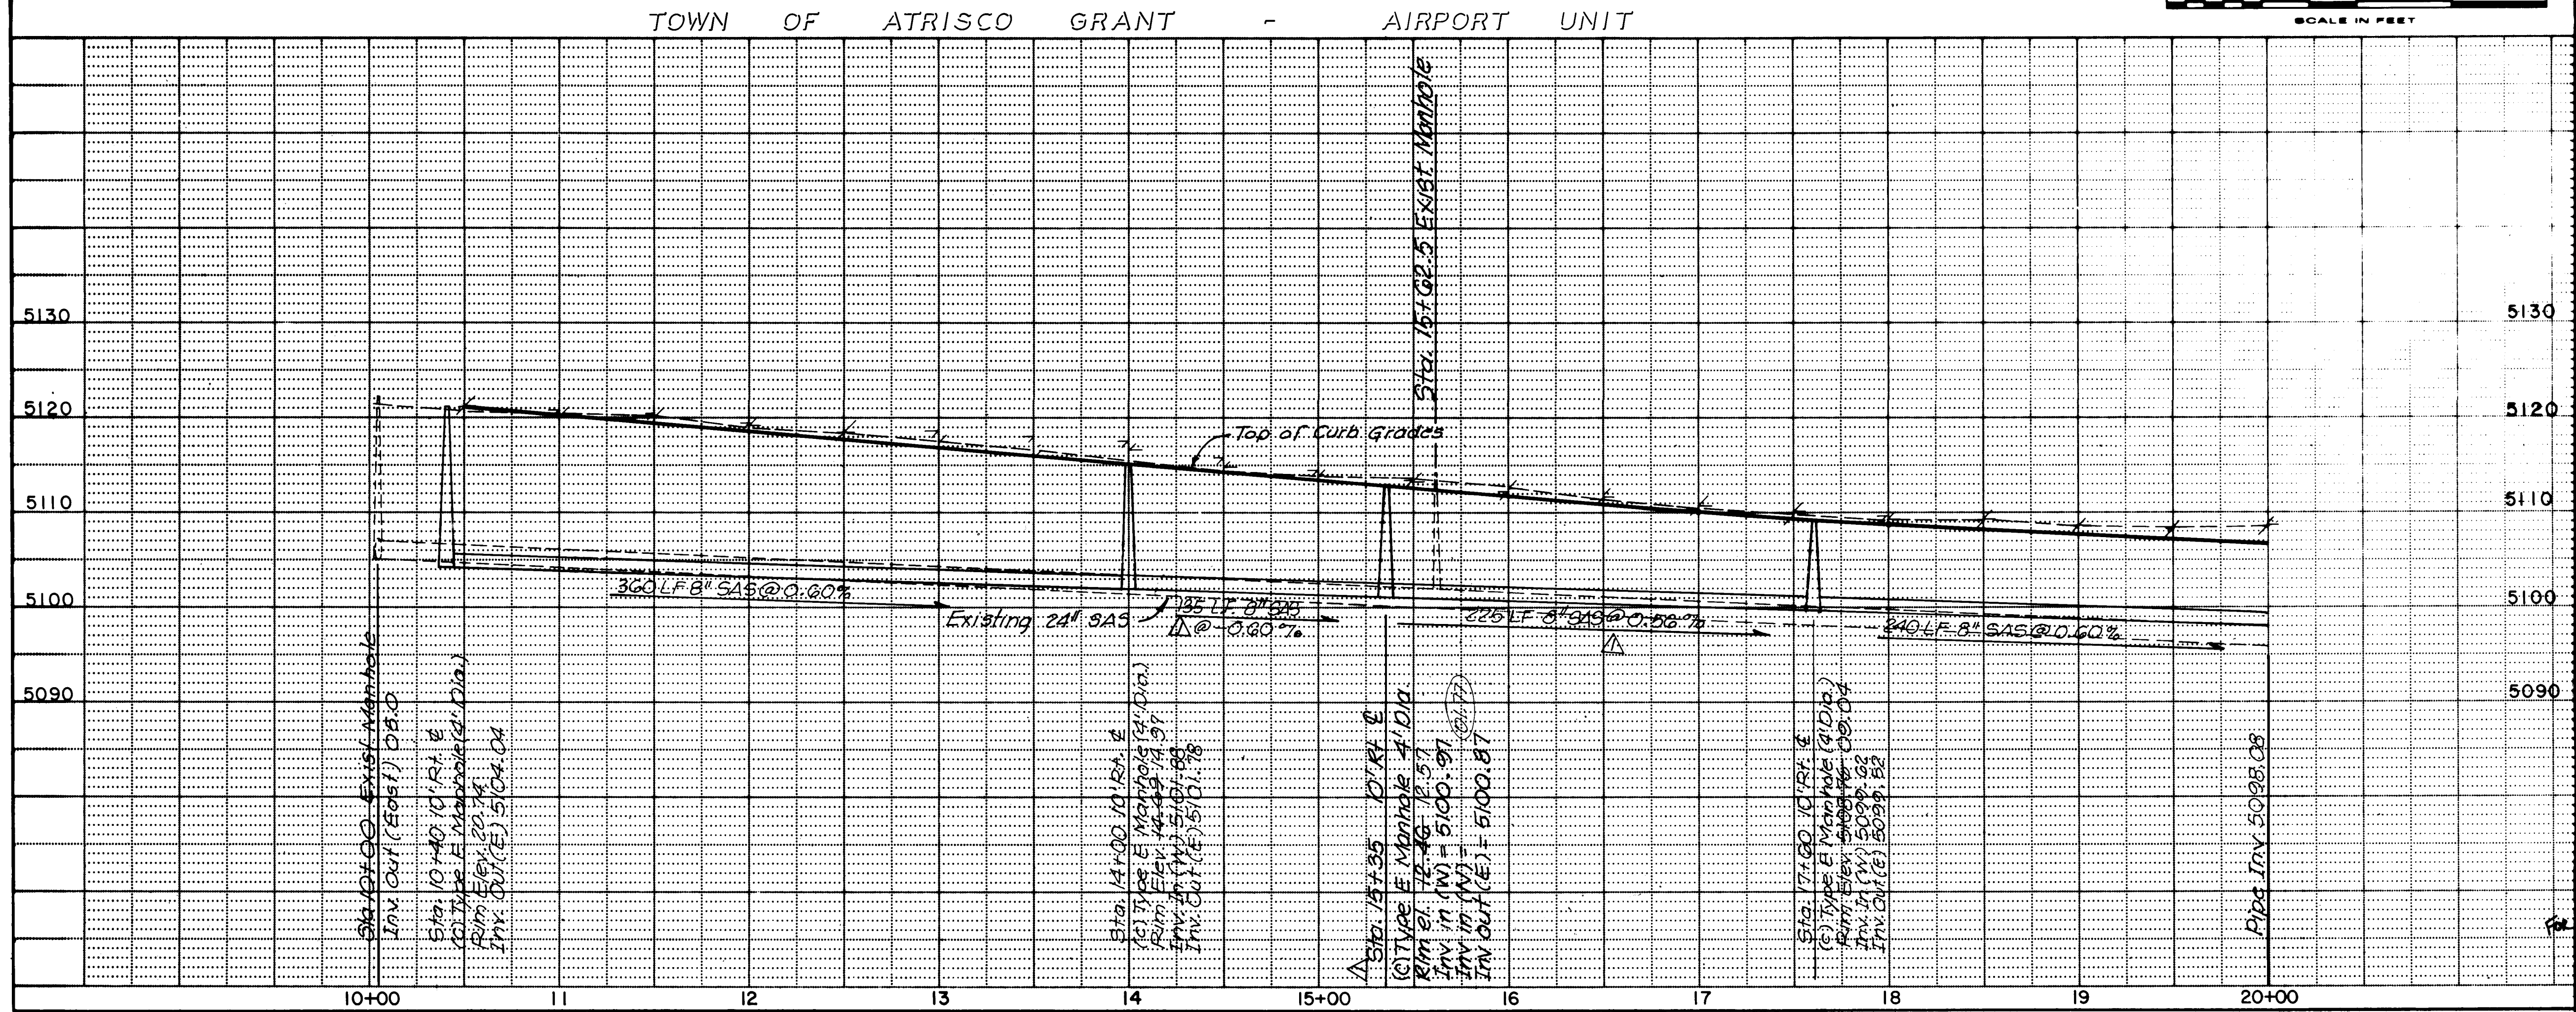

26 32292090
SAN. SEWER

CITY OF ALBUQUERQUE
PUBLIC WORKS DEPARTMENT
SPECIAL ASSESSMENT DISTRICT NO. 218

ILIFF ROAD

APPROVALS	ENGINEER	DATE	APPROVALS	ENGINEER	DATE
City Engineer	Rogers	3-14-89	Liquid Waste	Wilson	3-16-89
A-E-Design	"	"	Traffic	"	3-14-89
A-E-Hydrology	CAM	3-7-89	Water	"	3-16-89


DRAWING NO. **3229** MAP NO. H-10 & J-10 SHEET **20** OF **52**

RECORD DRAWING
DATE **3-1-90**

WILSON & COMPANY
ENGINEERS & ARCHITECTS
ALBUQUERQUE, NEW MEXICO
97-514

ENGINEER'S SEAL		SURVEY INFORMATION		BENCH MARKS		AS BUILT INFORMATION	
		NO.	BY	DATE	TBM #8 - Sta. 2173.3 - 38.5' At E	CONTRACTOR	UNIVERSAL CONSTRUCTION
					72nd Sheet - RR Spike in P Pole	STAFFED BY	BMA
					Elevation 5123.02	INSPECTIONS	DATE 6-88
						FIELD	DATE 2-90
						VERIFICATION BY	DATE 12-88
						CORRECTED BY	DATE 3-90
						RECORDED BY	DATE
						NO.	DATE

NOTE
See Sheet No. 49 for Details
of Drainage Storage Ponds.

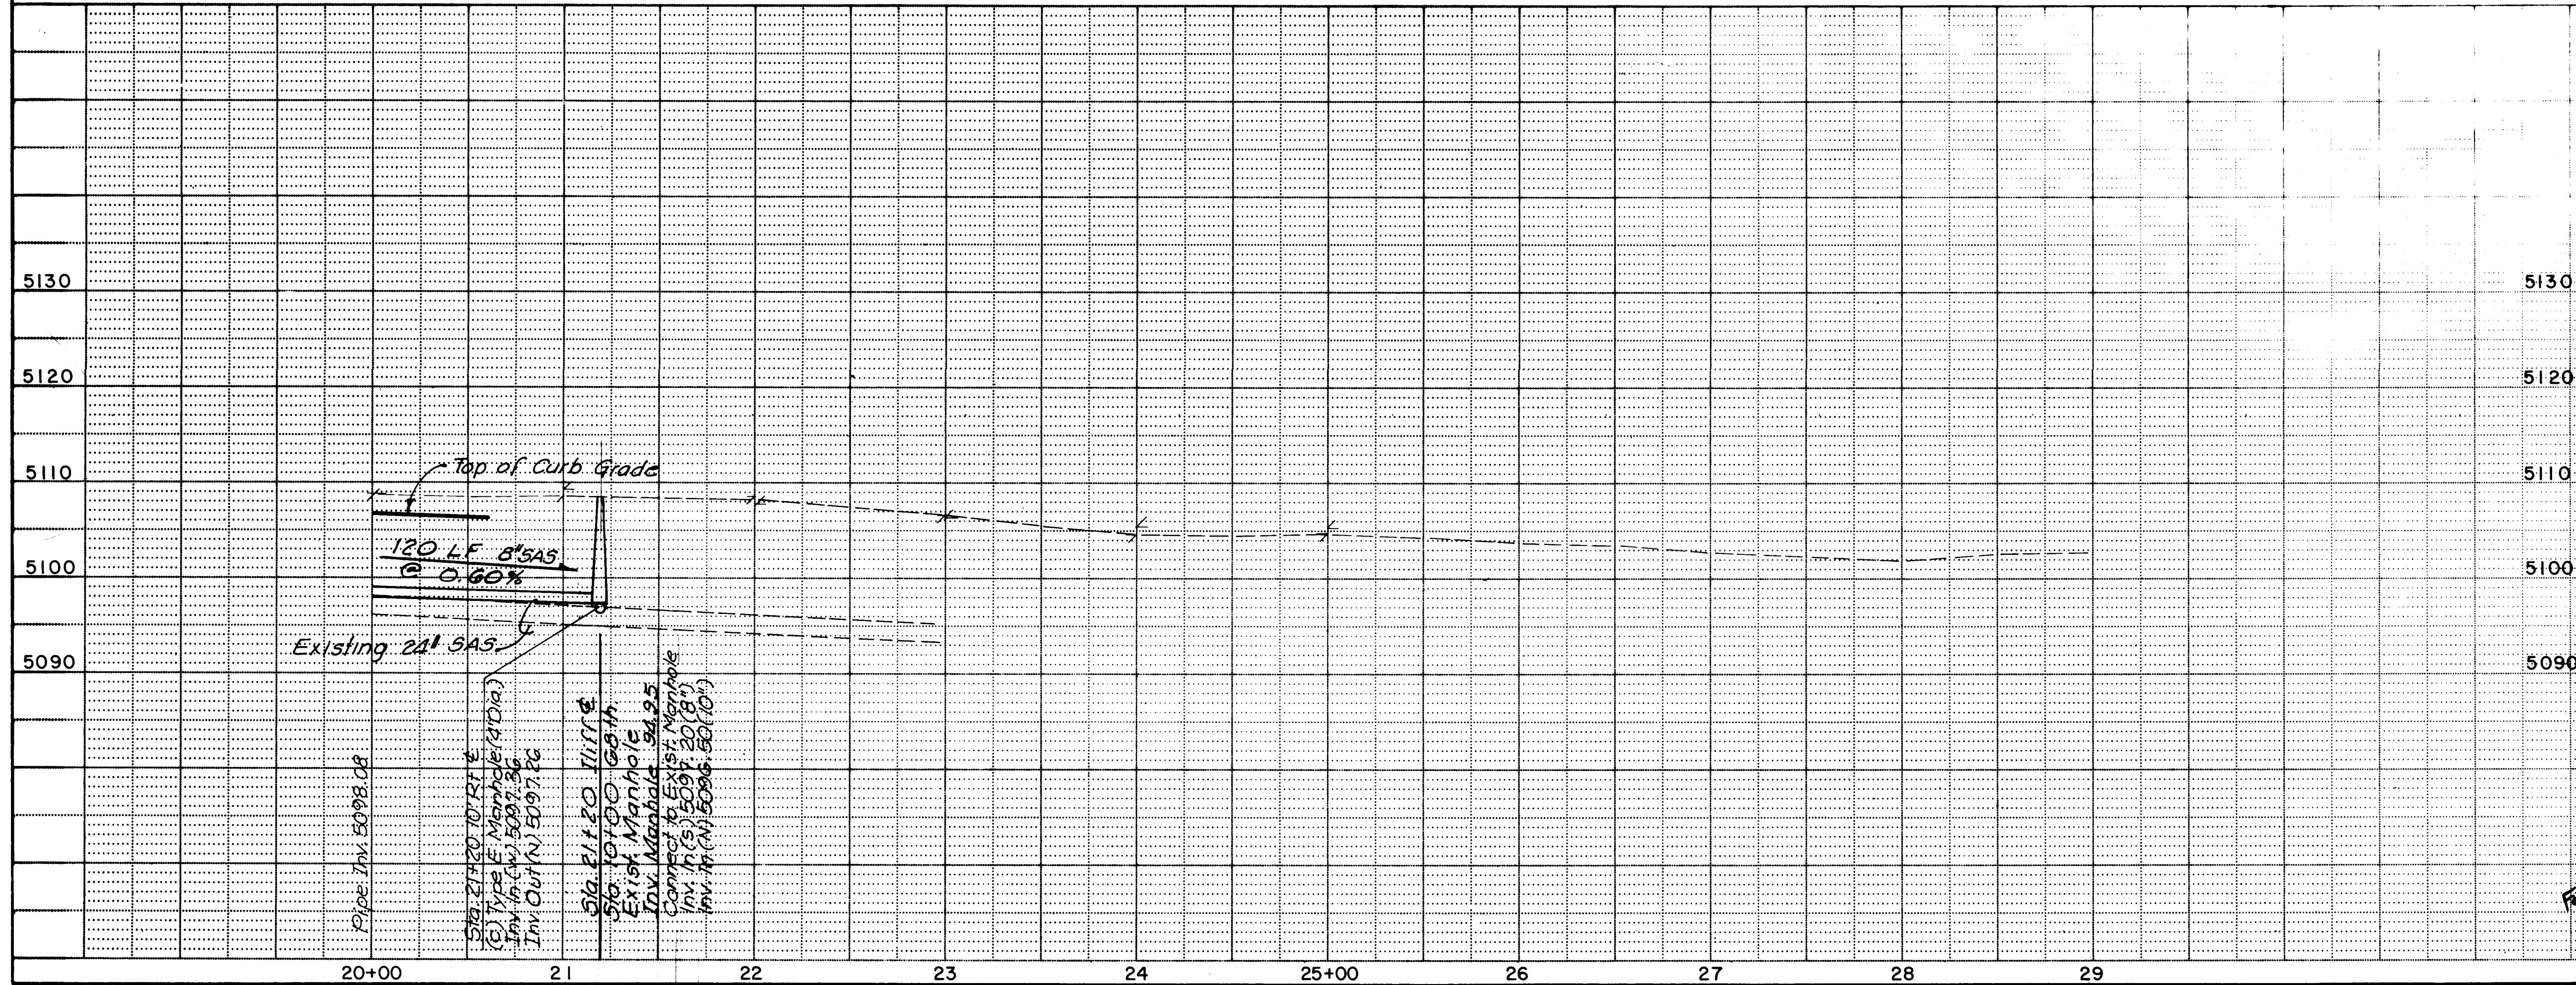

1	2	3	4	5	6	7	8	9	10	11	12
2	6		3	2	2	9	2	1	9	0	


ILIFF ROAD

APPROVALS	ENGINEER	DATE	APPROVALS	ENGINEER	DATE
City Engineer	Rogers	3-14-89	Liquid Waste	Blum	3-16-89
A-E-E - Design	"	"	Traffic	A. Blum	3-14-89
A-E-E - Hydrology	CAM NA	3-7-89	Water	Blum	3-16-89

DRAWING NO.	3229	MAP NO. H-10 & J-10	SHEET 21	OF 52
----------------	-------------	------------------------	--------------------	-----------------

RECORD DRAWING
DATE 3-1-90

GARDNER, MASON & ASSOCIATES, INC. ENGINEERS & PLANNERS ALBUQUERQUE, N.M.	WILSON COMPANY ENGINEERS & ARCHITECTS ALBUQUERQUE NEW MEXICO	87-514
---	---	---------------

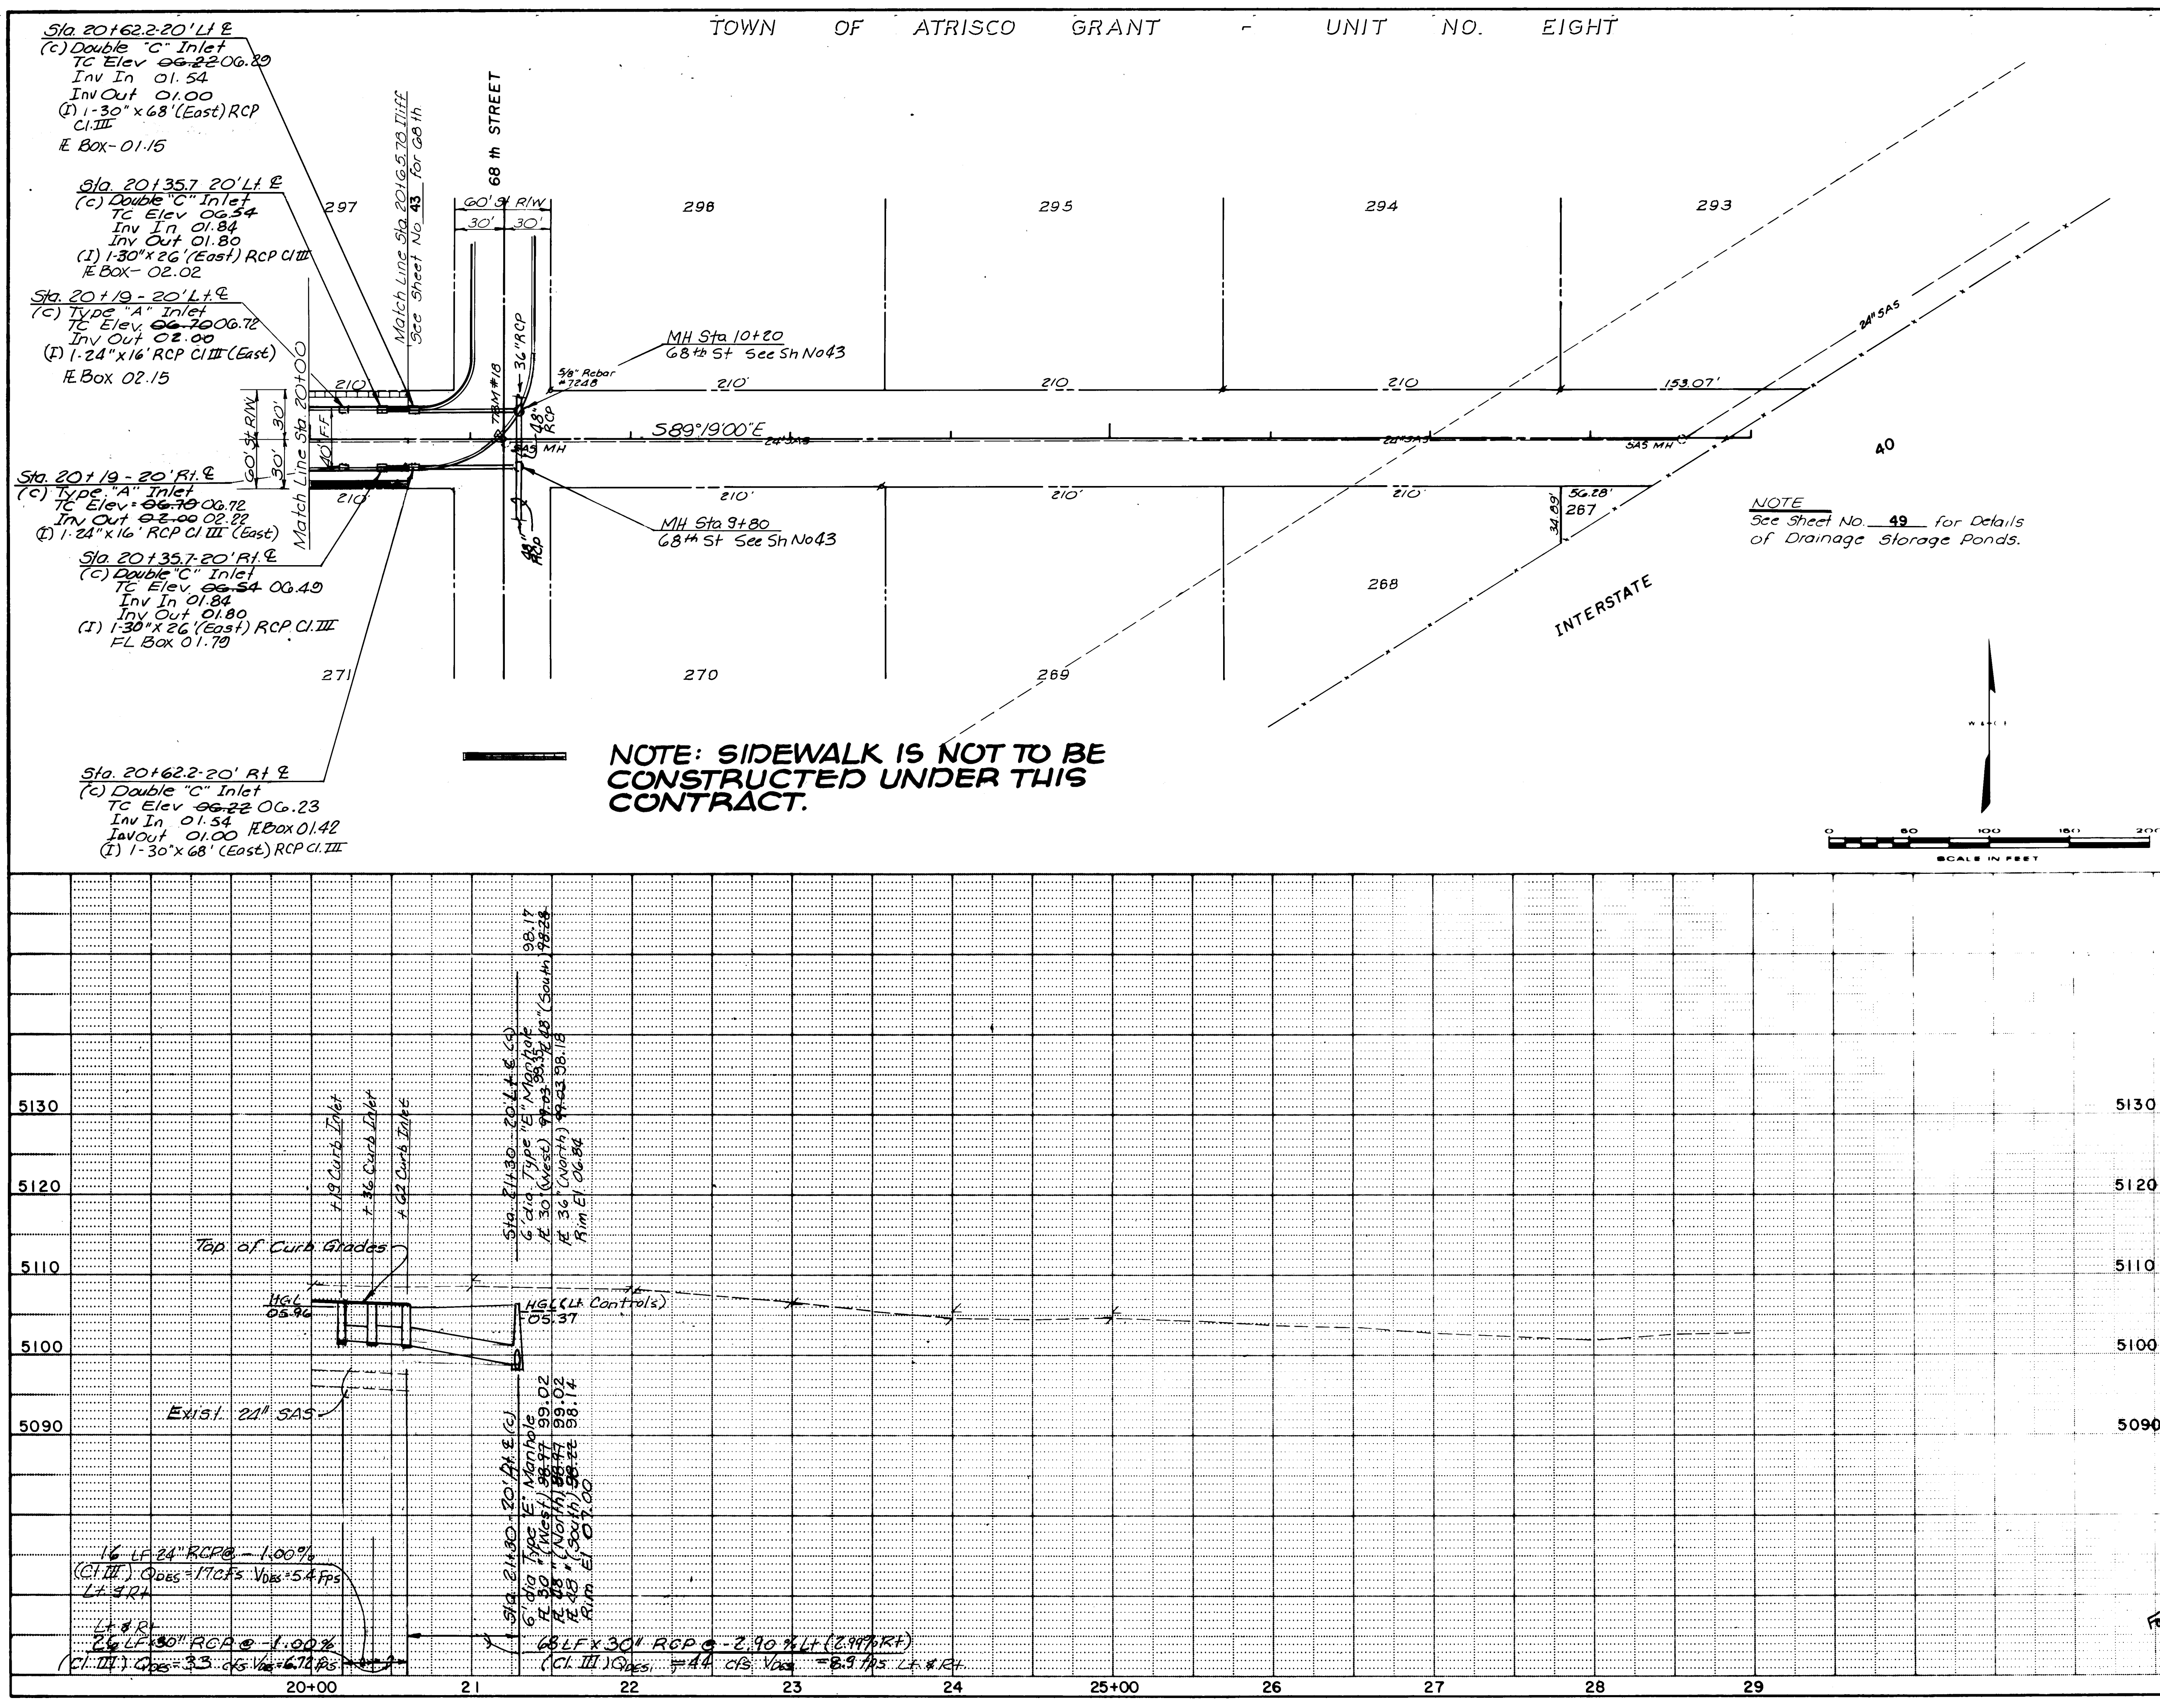

NOTE: SIDEWALK IS NOT TO BE
CONSTRUCTED UNDER THIS
CONTRACT.

NOTE
See Sheet No. 49 for Details
of Drainage Storage Ponds.



STORM DRAIN

CITY OF ALBUQUERQUE
PUBLIC WORKS DEPARTMENT
SPECIAL ASSESSMENT DISTRICT NO. 218

ILLIFF ROAD

APPROVALS	ENGINEER	DATE	APPROVALS	ENGINEER	DATE
City Engineer	Rogers	3-14-89	Liquid Waste	Rogers	3-14-89
Design			Traffic	Rogers	3-14-89
Hydrology	C.M.	3-7-89	Water	Rogers	3-14-89

DRAWING NO. **3229** MAP NO. H-10 & J-10 SHEET **22** OF **52**

RECORD DRAWING
DATE 3-1-90

GARDNER, MASON & ASSOCIATES, INC.
ENGINEERS & PLANNERS
ALBUQUERQUE, N.M.


WILSON & COMPANY
ENGINEERS & ARCHITECTS
ALBUQUERQUE, NEW MEXICO

87-514

SURVEY INFORMATION		BENCH MARKS		AS BUILT INFORMATION	
NO.	BY	DATE		CONTRACTOR	UNIVERSAL CONSTRUCTION
				WORK	DATE 8-89
				INSPECTOR'S	DATE 2-90
				FIELD	DATE 2-90
				VERIFICATION BY	DATE 12-89
				CORRECTED BY	DATE 3-90
				MICRO-FILM INFORMATION	
				RECORDED BY	DATE
				NO	


ENGINEER'S SEAL		REVISIONS	
		NO.	DATE
		DATE	DATE
		DATE	DATE
		DATE	DATE

WILSON & COMPANY, ENGINEERS & ARCHITECTS

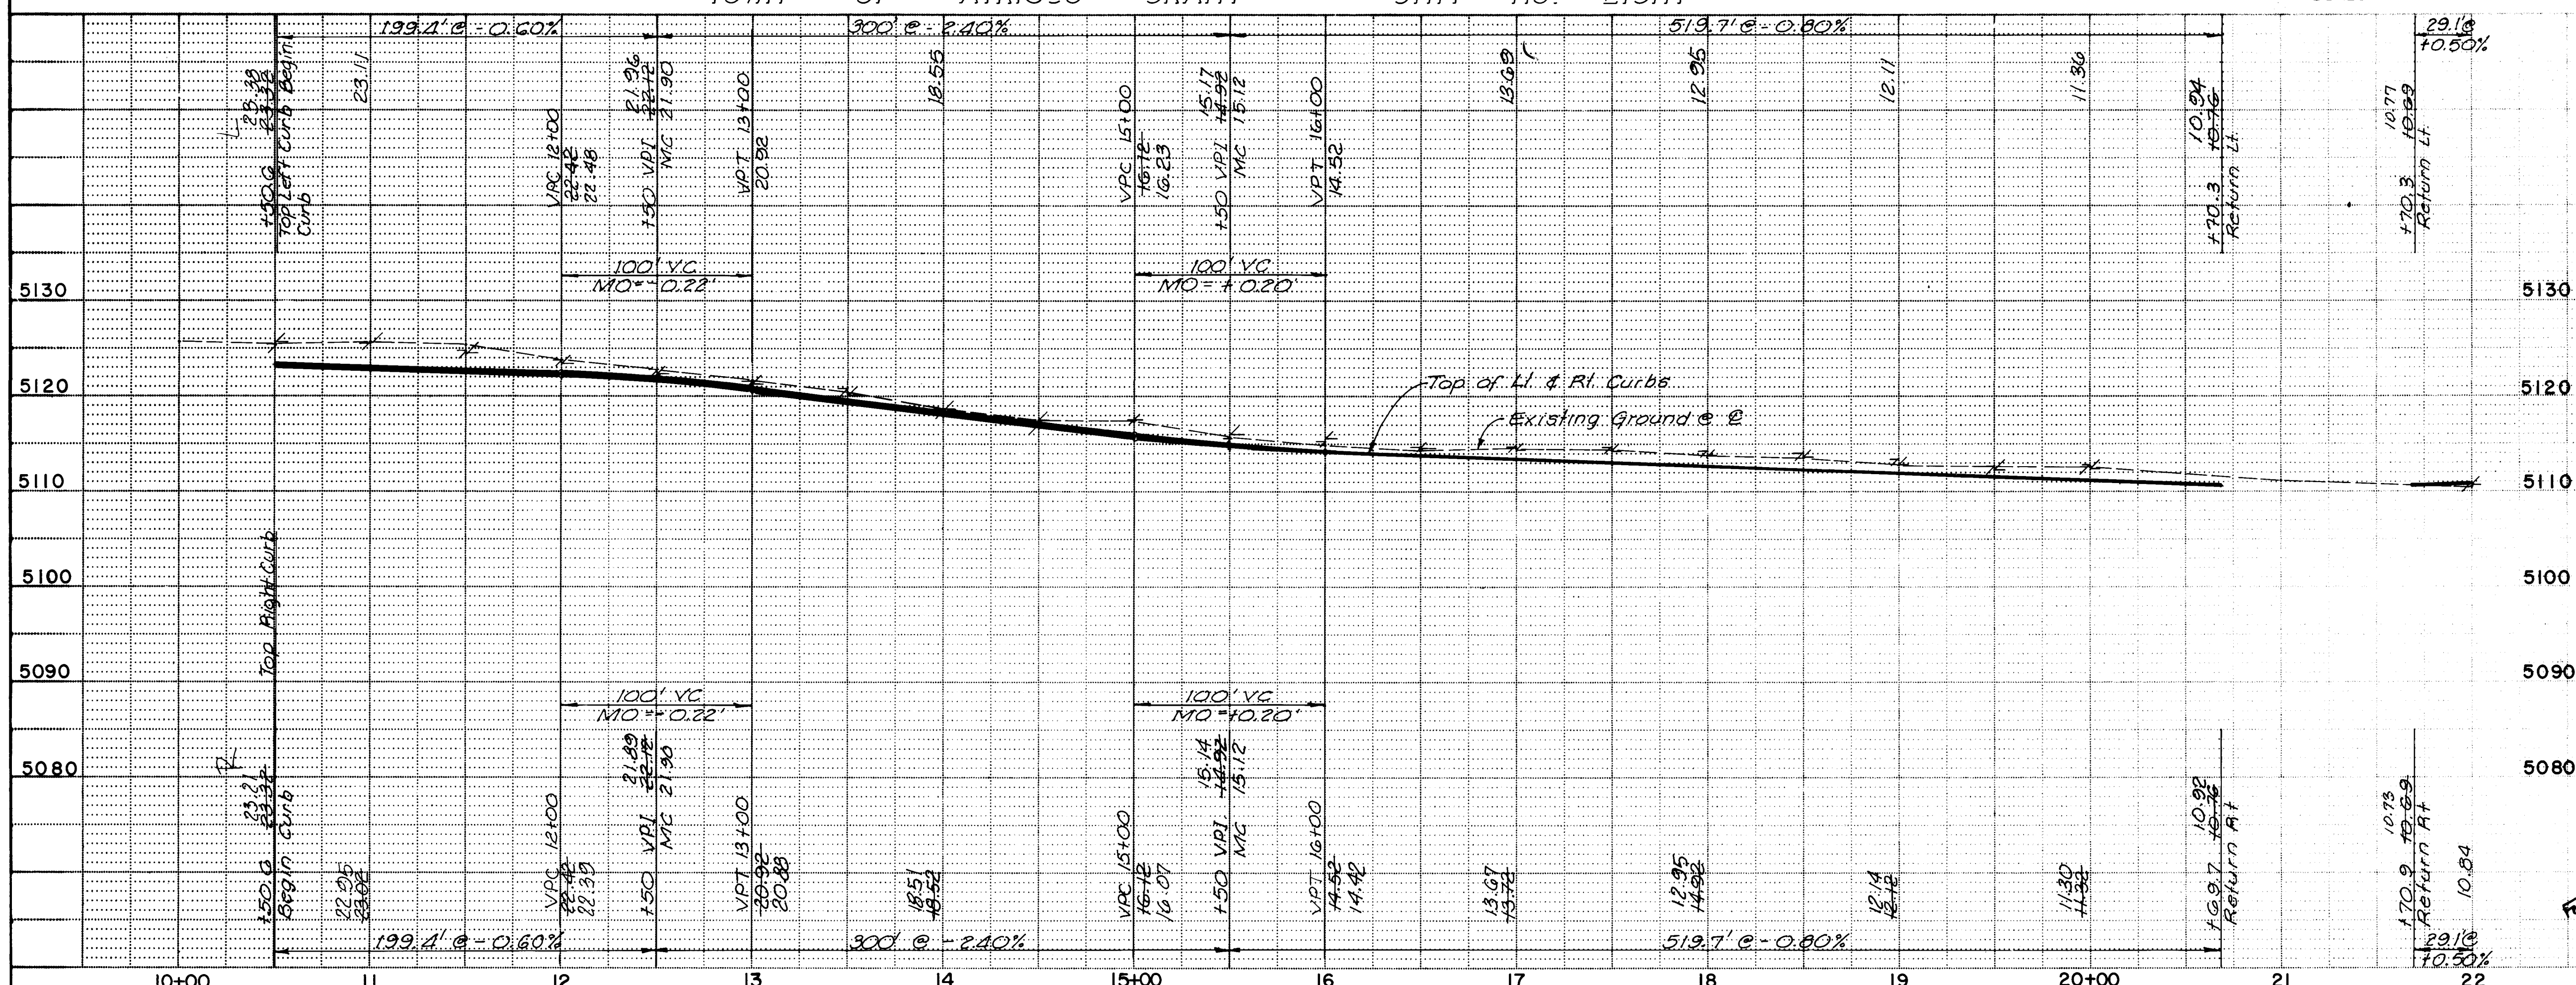

GARDNER, MASON & ASSOCIATES, INC. **WILSON & COMPANY** **87-514**
ENGINEERS & PLANNERS **ENGINEERS & ARCHITECTS**
ALBUQUERQUE, N.M. **ALBUQUERQUE, NEW MEXICO**

NO	DATE	REMARKS	BY
REVISIONS			
WILSON B. COMPANY ENGINEERS & ARCHITECTS			
DESIGNED BY		DATE	
DRAWN BY		DATE	
CHECKED BY		DATE	

 

TOWN OF ATRISCO GRANT - UNIT NO. EIGHT

PAVING

CITY OF ALBUQUERQUE
PUBLIC WORKS DEPARTMENT
SPECIAL ASSESSMENT DISTRICT NO. 218

JUNIPER ROAD

APPROVALS	ENGINEER	DATE	APPROVALS	ENGINEER	DATE
City Engineer	<i>Roger A. Hagan</i>	3-4-89	Liquid Waste	<i>ASO</i>	3/6/89
ACE - Design	"	"	Traffic	<i>Roger A. Hagan</i>	3-4-89
ACE - Hydrology	<i>CAM</i>	3-7-89	Water	<i>ASO</i>	3/6/89

DRAWING NO.	3229	MAP NO.	H-10 & J-10	SHEET	24	OF	52
-------------	-------------	---------	-------------	-------	-----------	----	-----------


RECORD DRAWING
DATE 3-1-90

GARDNER, MASON & ASSOCIATES, INC.
ENGINEERS & PLANNERS
ALBUQUERQUE, N.M.

WILSON & COMPANY
ENGINEERS & ARCHITECTS
ALBUQUERQUE NEW MEXICO

87-514

[illegible]

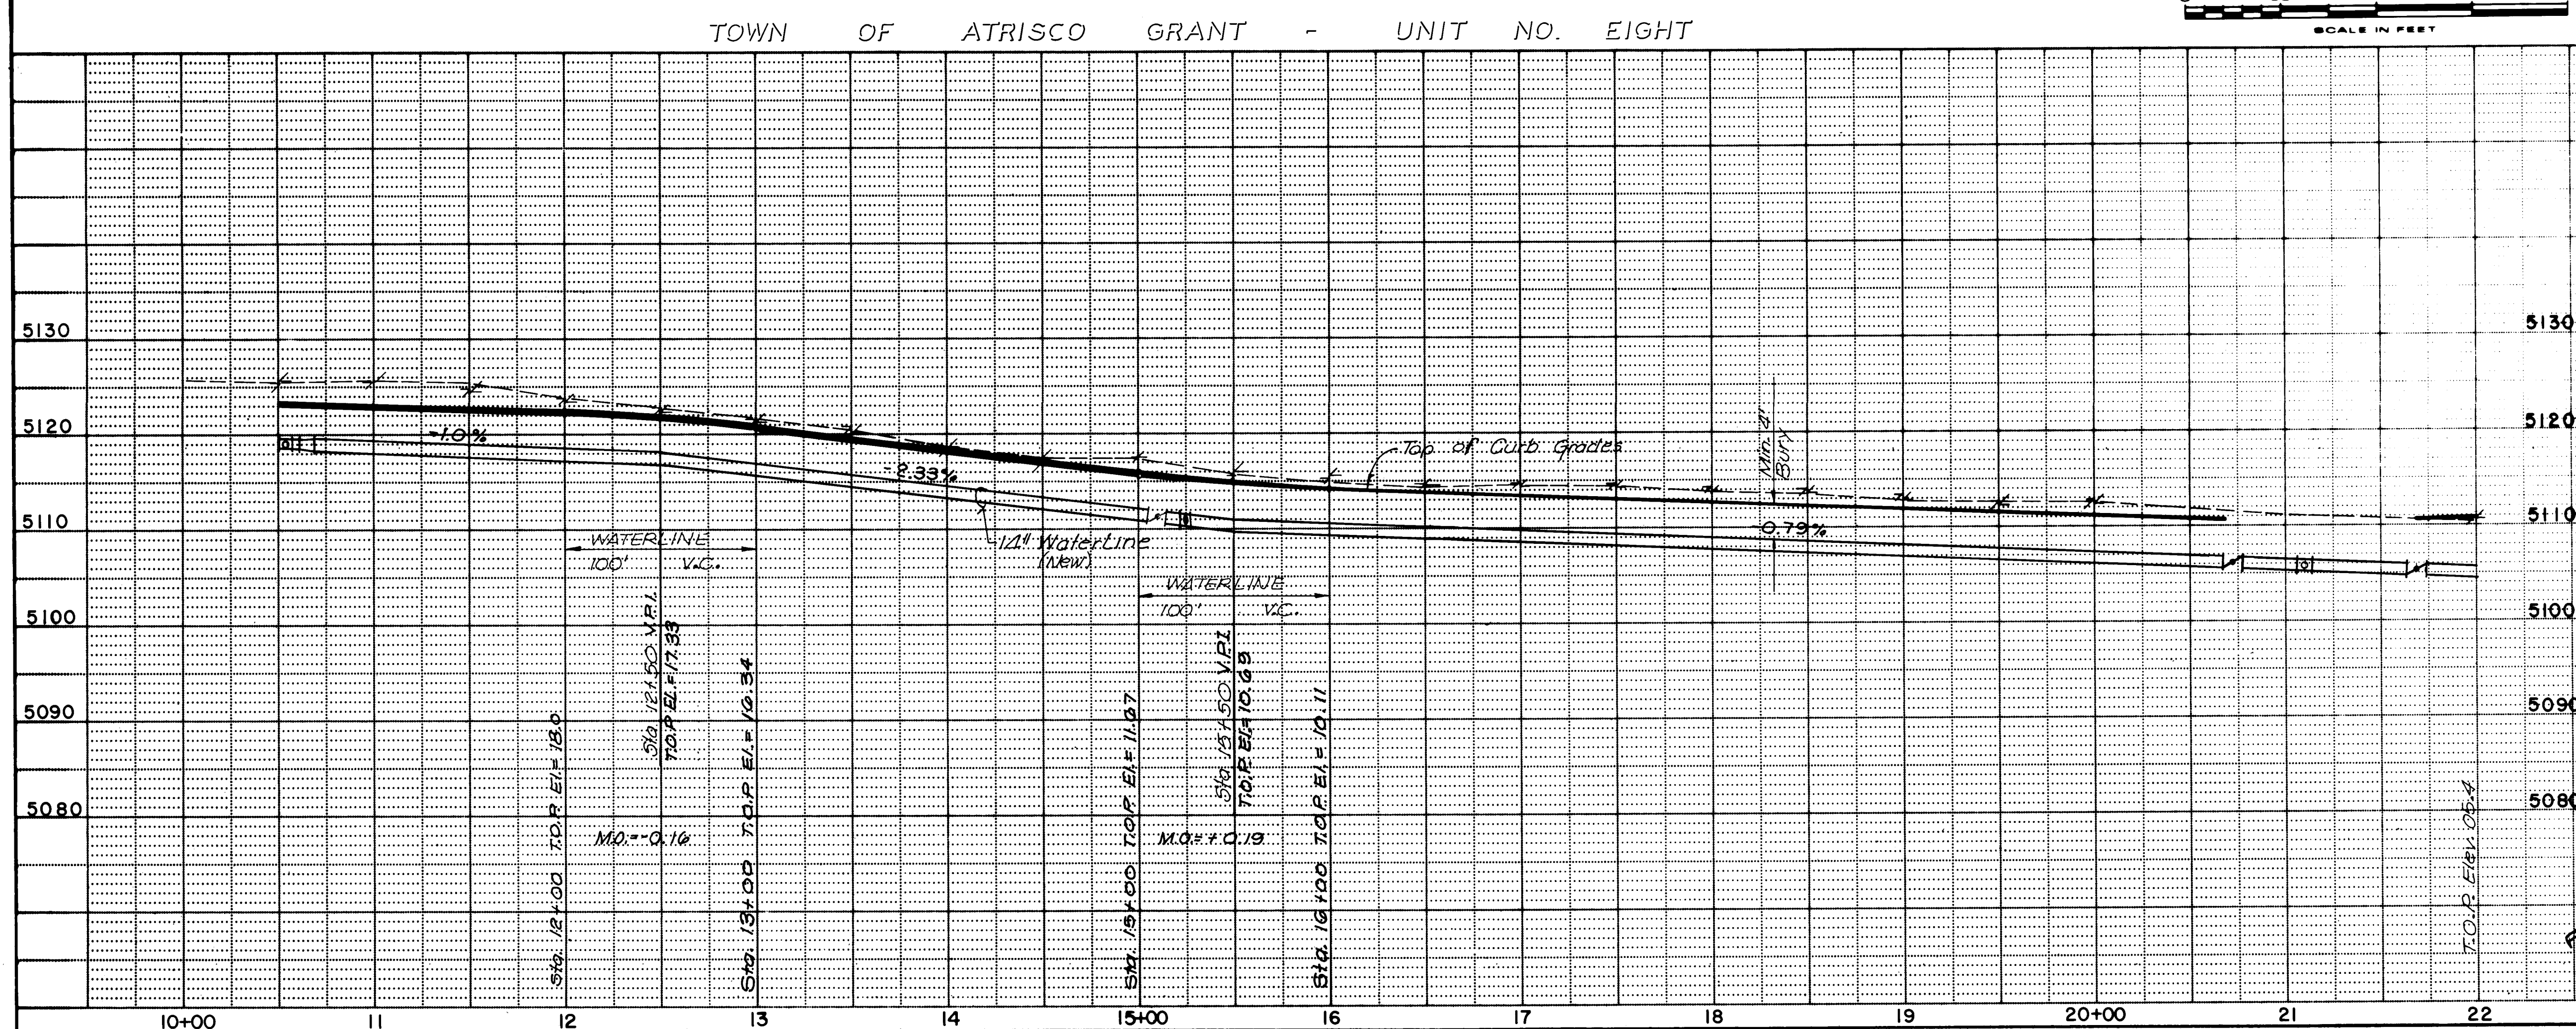

A horizontal scale bar with markings at 0, 50, 100, 150, and 200 feet. The bar is divided into segments by vertical lines, with the 50-foot segments being longer than the 10-foot segments. The text "SCALE IN FEET" is centered below the bar.

26 32292590

WATER

CITY OF ALBUQUERQUE
PUBLIC WORKS DEPARTMENT
SPECIAL ASSESSMENT DISTRICT NO. 218

JUNIPER ROAD

APPROVALS	ENGINEER	DATE	APPROVALS	ENGINEER	DATE
City Engineer	<i>Robert J. Green</i>	3-14-89	Liquid Waste	<i>Robert J. Green</i>	3/6/89
A.C.E. - Design	<i>u</i>	<i>u</i>	Traffic	<i>Robert J. Green</i>	3-14-89
A.C.E. - Hydrology	<i>CAM NA</i>	8-7-85	Water	<i>Robert J. Green</i>	3/6/89



DRAWING NO.	3229	MAP NO. H-10 & J-10	SHEET 25 OF 52
-------------	-------------	------------------------	------------------------------

RECORD DRAWING
DATE 3-1-90

GARDNER, MASON & ASSOCIATES, INC.
ENGINEERS & PLANNERS
ALBUQUERQUE, N.M.

WILSON & COMPANY
ENGINEERS & ARCHITECTS
ALBUQUERQUE NEW MEXICO

87-514

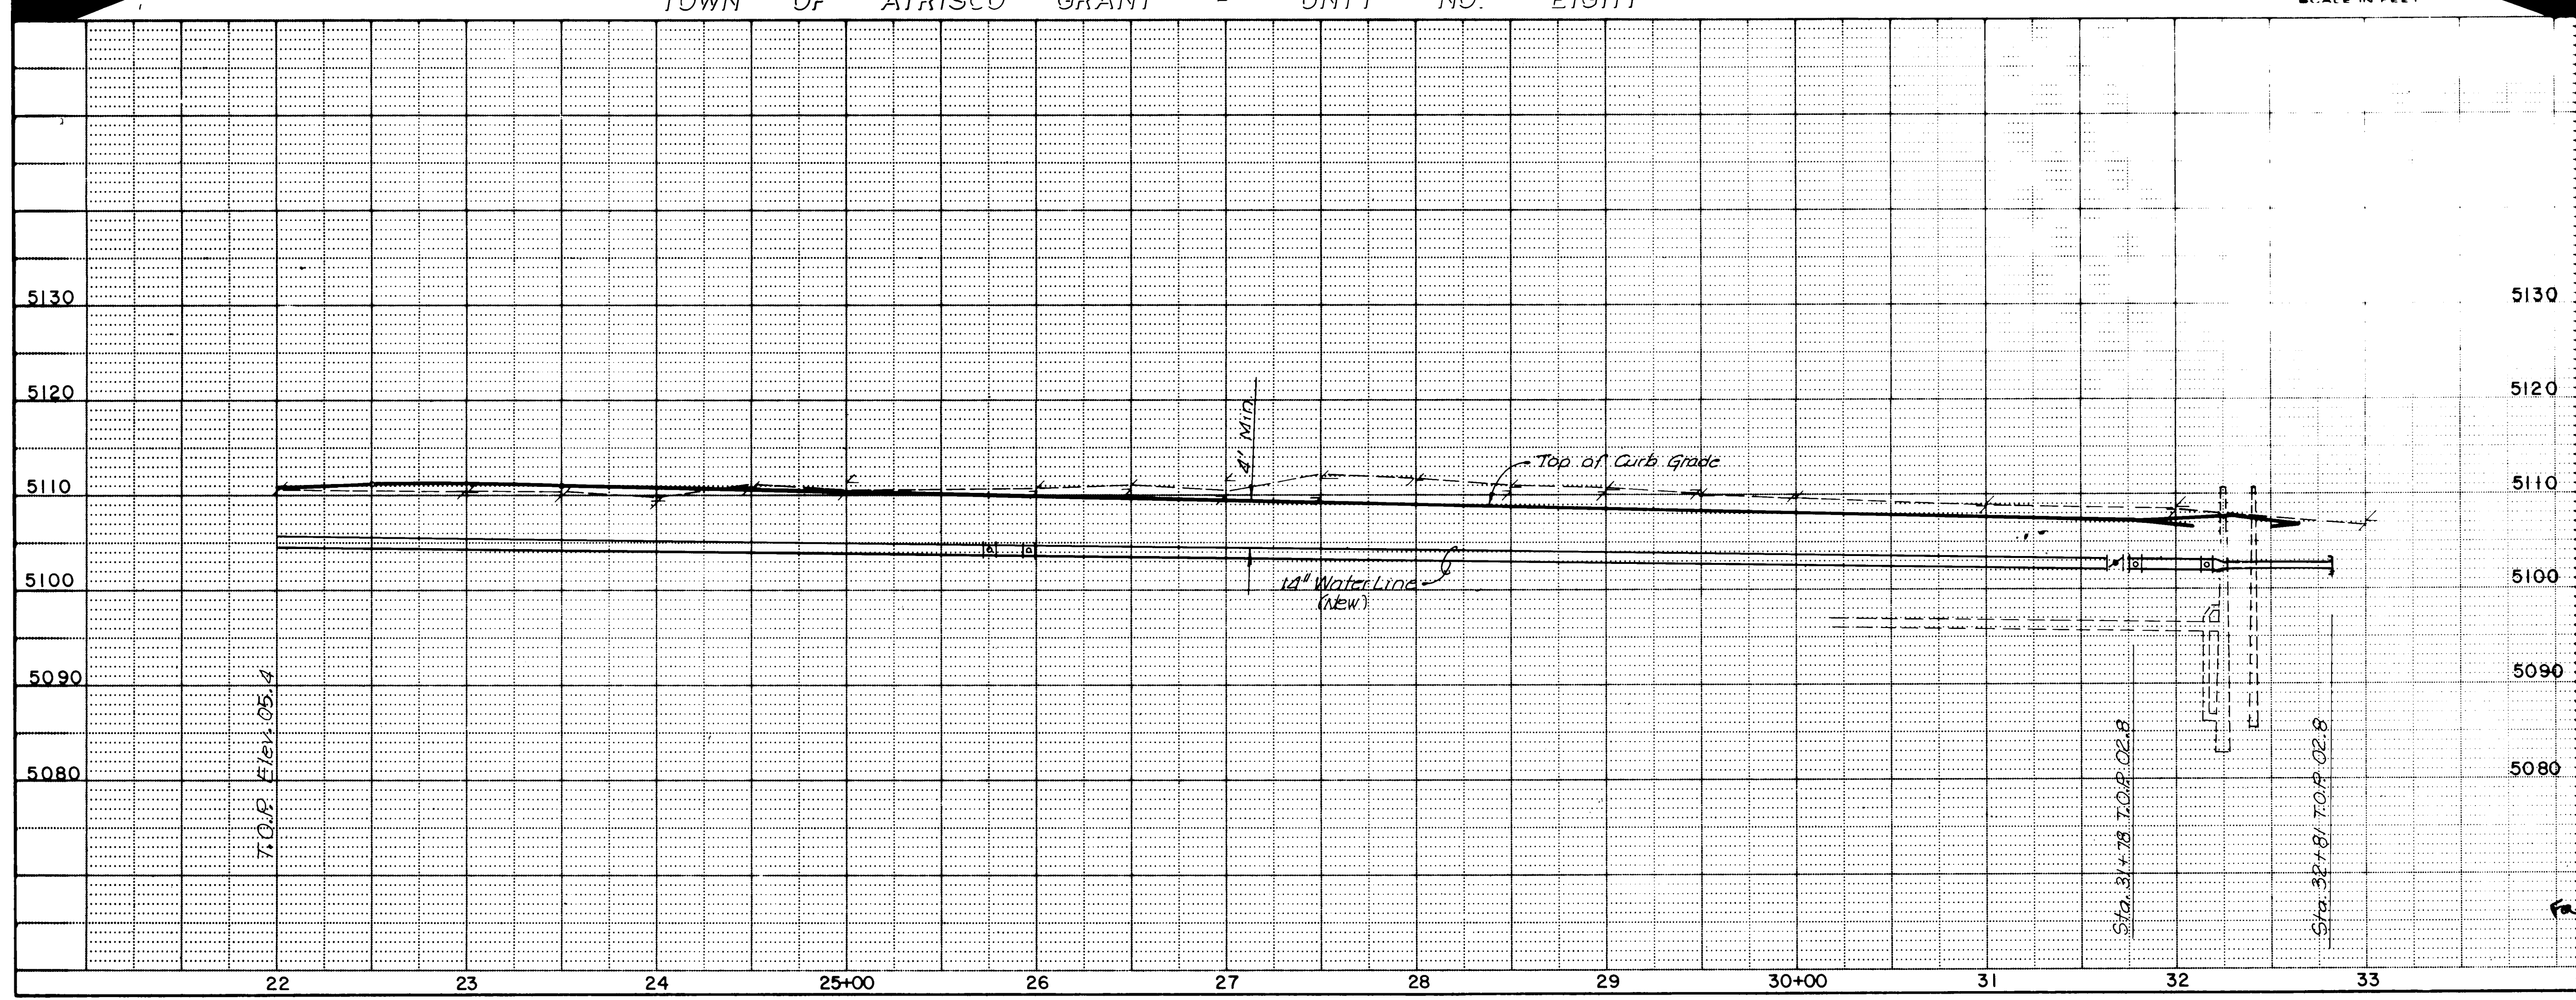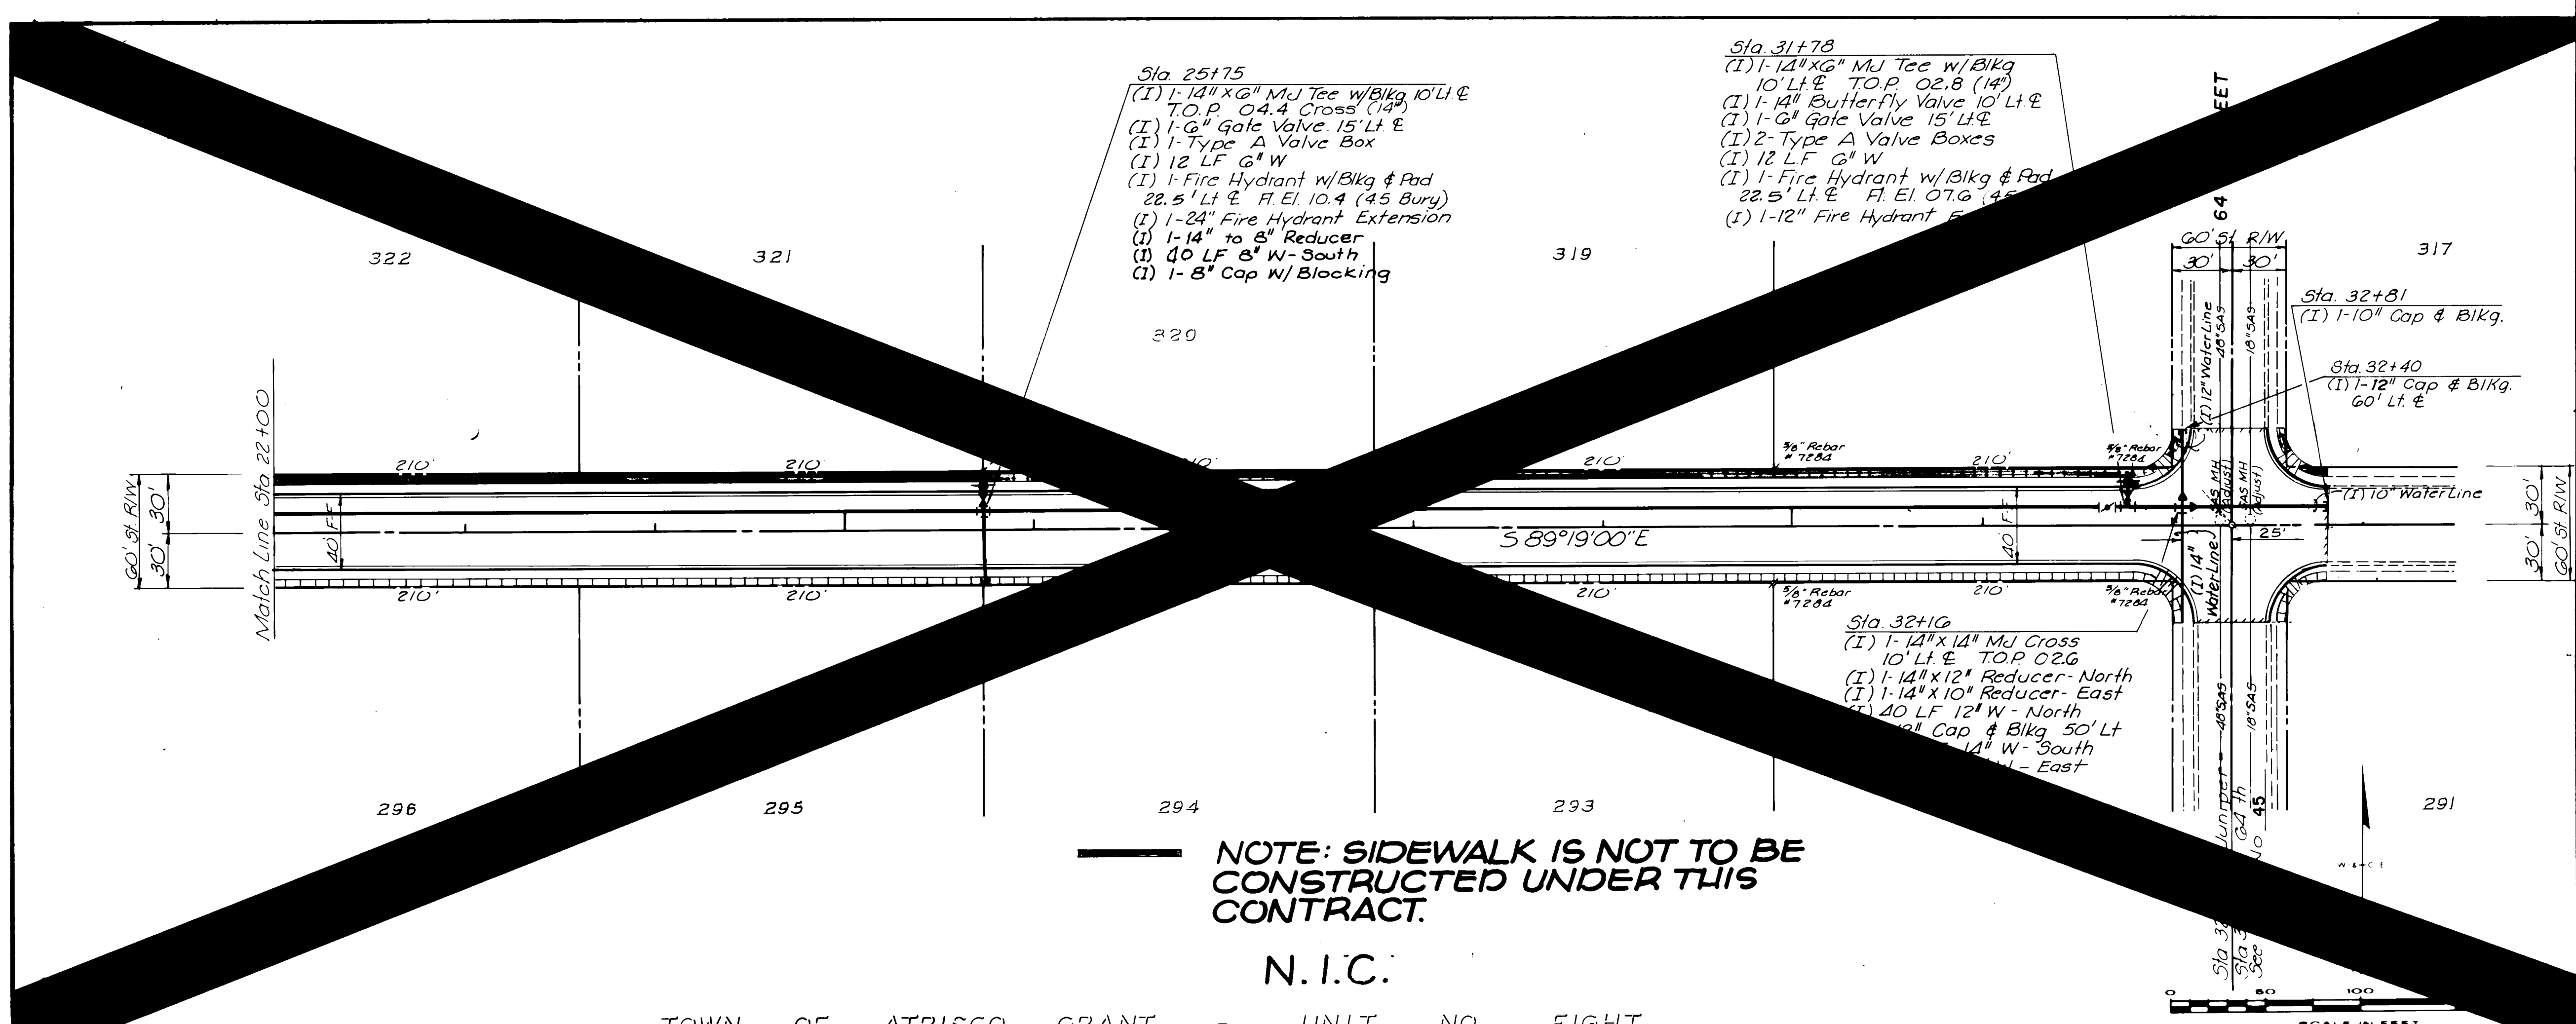



ENGINEER'S SEAL			SURVEY INFORMATION		BENCH MARKS		AS BUILT INFORMATION		
			FIELD NOTES		TBM #1 - Sta. 3212G - 3' Lt. E		CONTRACTOR UNIVERSAL CONSTRUCTION		
			NO.	BY	DATE	NO.	BY	DATE	
REVISIONS WILSON & COMPANY, ENGINEERS & ARCHITECTS			NO.	DATE	REMARKS	BY	DATE		
			DESIGNED BY						DATE
			DRAWN BY						DATE
			CHECKED BY						DATE
WATER									
CITY OF ALBUQUERQUE PUBLIC WORKS DEPARTMENT SPECIAL ASSESSMENT DISTRICT NO. 218									
JUNIPER ROAD									
APPROVALS		ENGINEER	DATE	APPROVALS		ENGINEER	DATE		
City Engineer		Ronald Green	3-14-91	Liquid Waste		REDO	3-16-91		
A-E-E - Design		u	u	Traffic		Ronald Green	3-14-91		
A-E-E - Hydrology		CAN	NA 3-7-89	Water		W. Quintero	3-16-91		
DRAWING NO.		3229		MAP NO.		H-10 & J-10			
SHEET		26		OF		52			

RECORD DRAWING
DATE 3-1-90

GARDNER, MASON & ASSOCIATES, INC.
ENGINEERS & PLANNERS
ALBUQUERQUE, N.M.

WILSON & COMPANY
ENGINEERS & ARCHITECTS
ALBUQUERQUE, NEW MEXICO

87-514

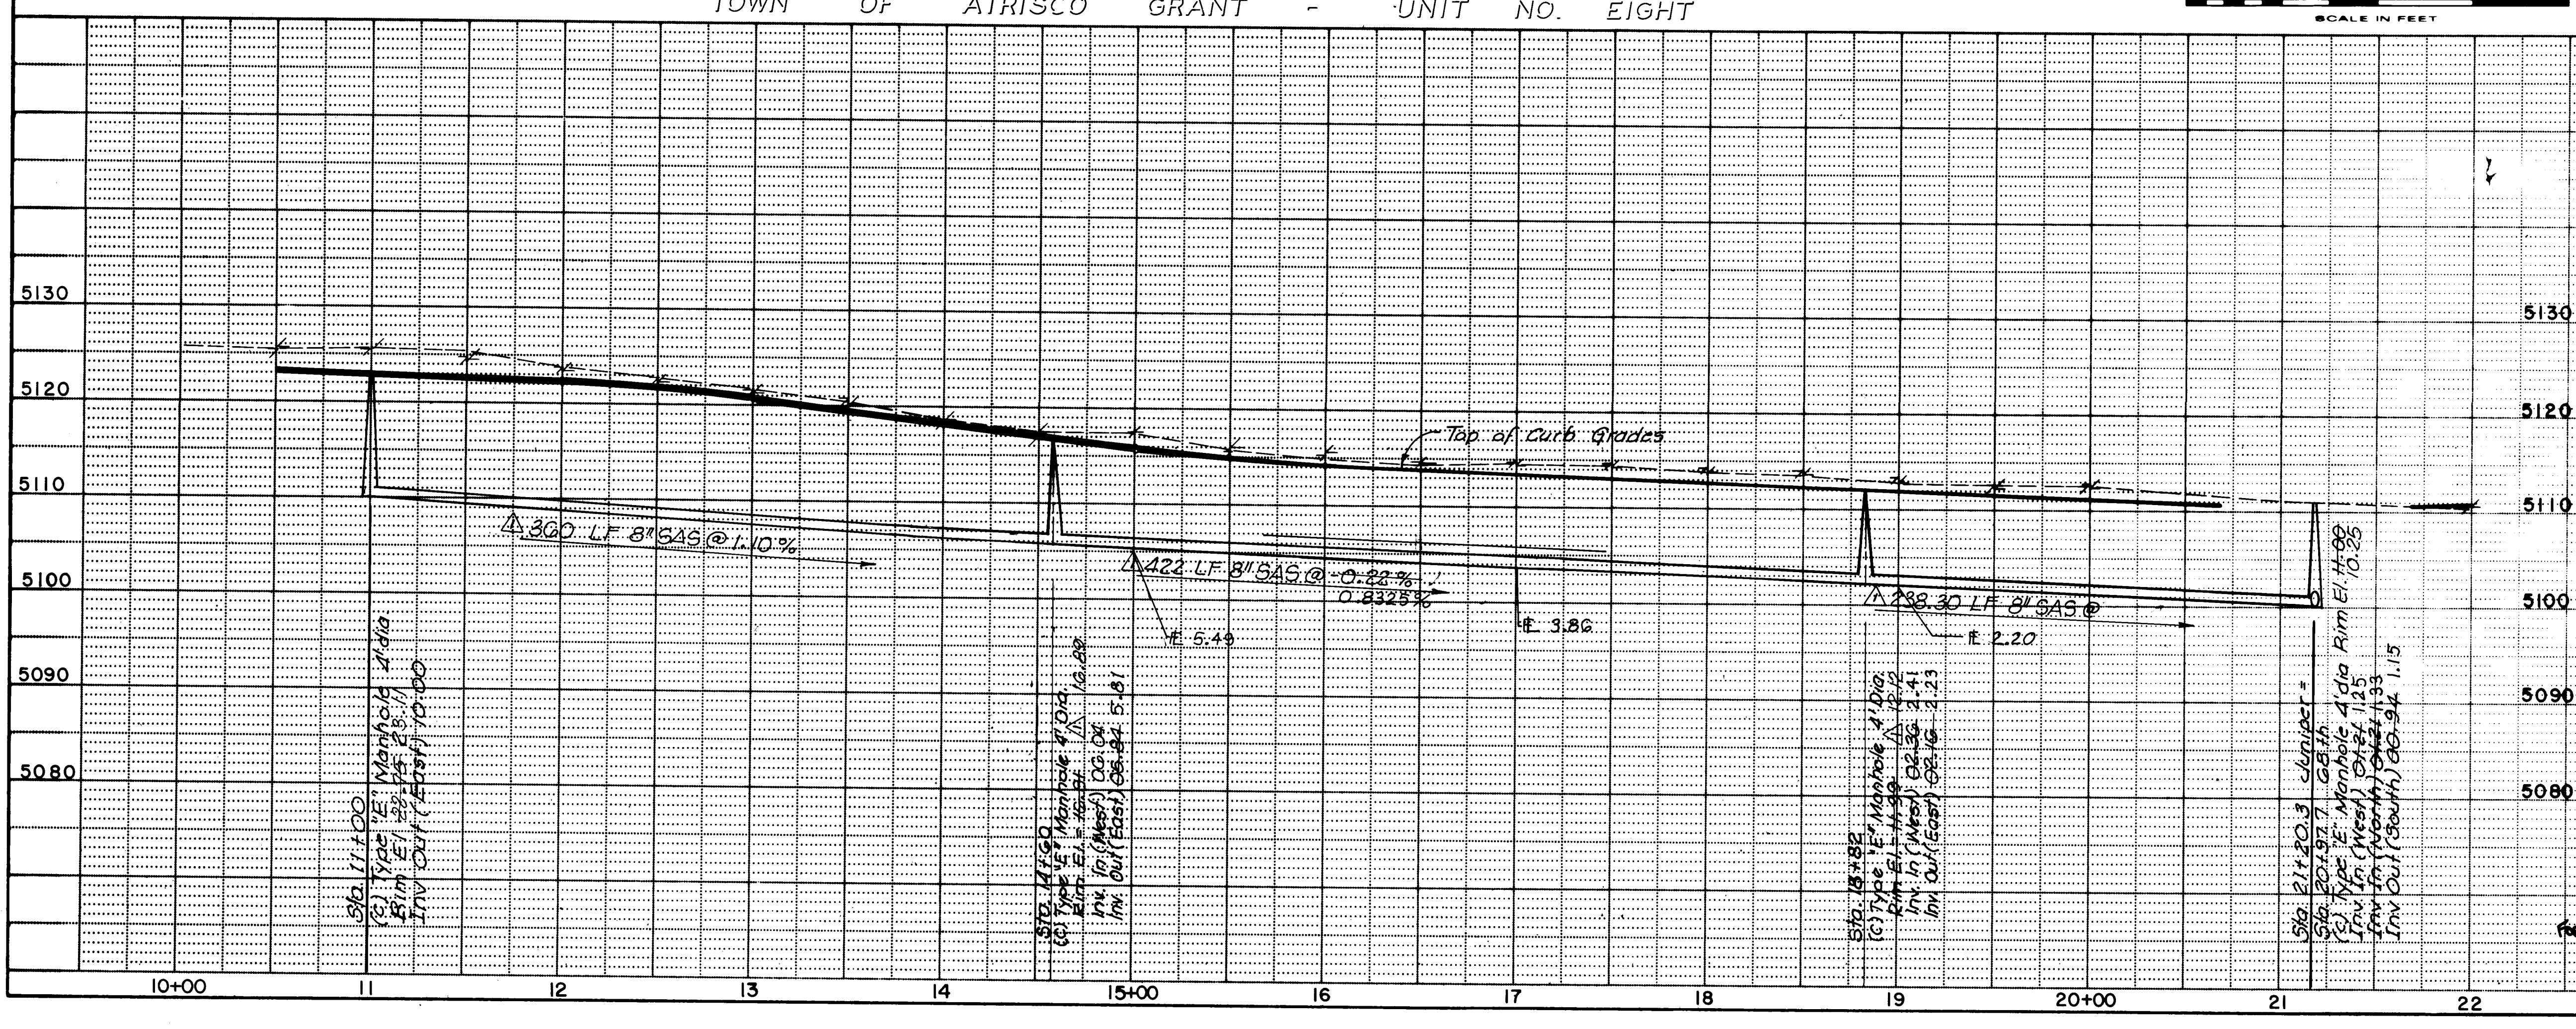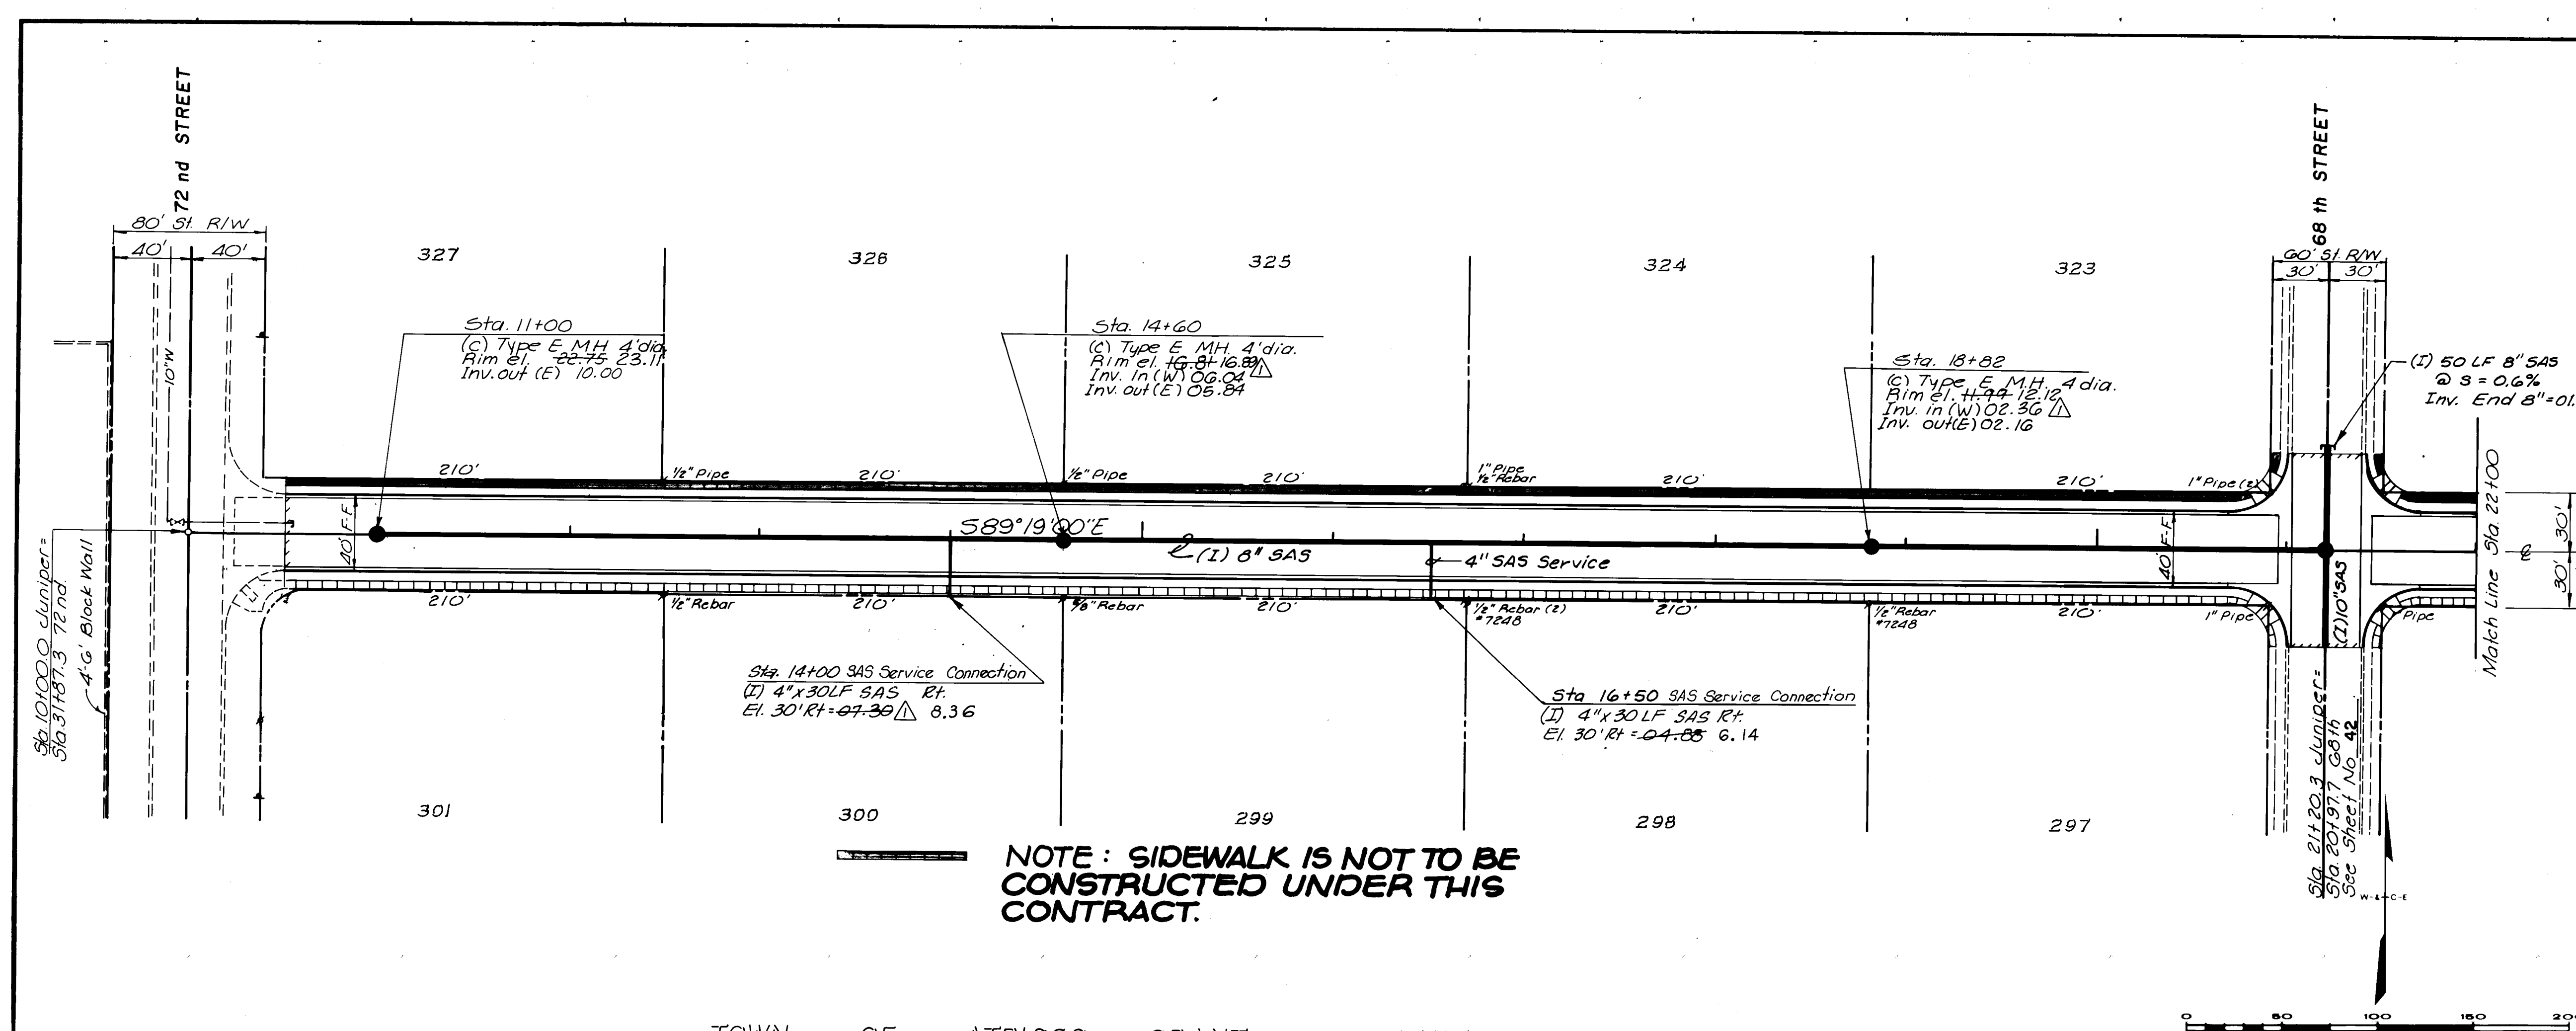


ENGINEER'S SEAL		AS BUILT INFORMATION	
		CONTRACTOR	UNIVERSAL CONSTRUCTION
		WORK BY	BMA
		INSPECTOR'S	
		ACCEPTANCE BY	R. HAMLEY
DATE		DATE	DATE
2-90		2-90	2-90
DESIGNED BY		DESIGNED BY	DESIGNED BY
DRAWN BY		DRAWN BY	DRAWN BY
CHECKED BY		CHECKED BY	CHECKED BY
DATE		DATE	DATE
3-1-90		3-1-90	3-1-90
REVISIONS		REVISIONS	
NO.	DATE	REMARKS	BY
1	3/1/90	Revised SAS Slopes & Elevations	SJM
WILSON & COMPANY, ENGINEERS & ARCHITECTS			
CITY OF ALBUQUERQUE PUBLIC WORKS DEPARTMENT SPECIAL ASSESSMENT DISTRICT NO. 218 JUNIPER ROAD			
APPROVALS		ENGINEER	DATE
City Engineer		Ray A. Shaw	3-14-89
A-E-E - Design		u	
A-E - Hydrology		CAM NA	3-7-89
APPROVALS		ENGINEER	DATE
Liquid Waste		W. H. H. H.	3/6/89
Traffic		W. H. H. H.	3-14-89
Water		W. H. H. H.	3/6/89
DRAWING NO.		3229	MAP NO. H-10 & J-10
SHEET		27	52

N.I.C.

NOTE: SIDEWALK IS NOT TO BE CONSTRUCTED UNDER THIS CONTRACT.

TOWN OF ATRISCO GRANT - UNIT NO. EIGHT

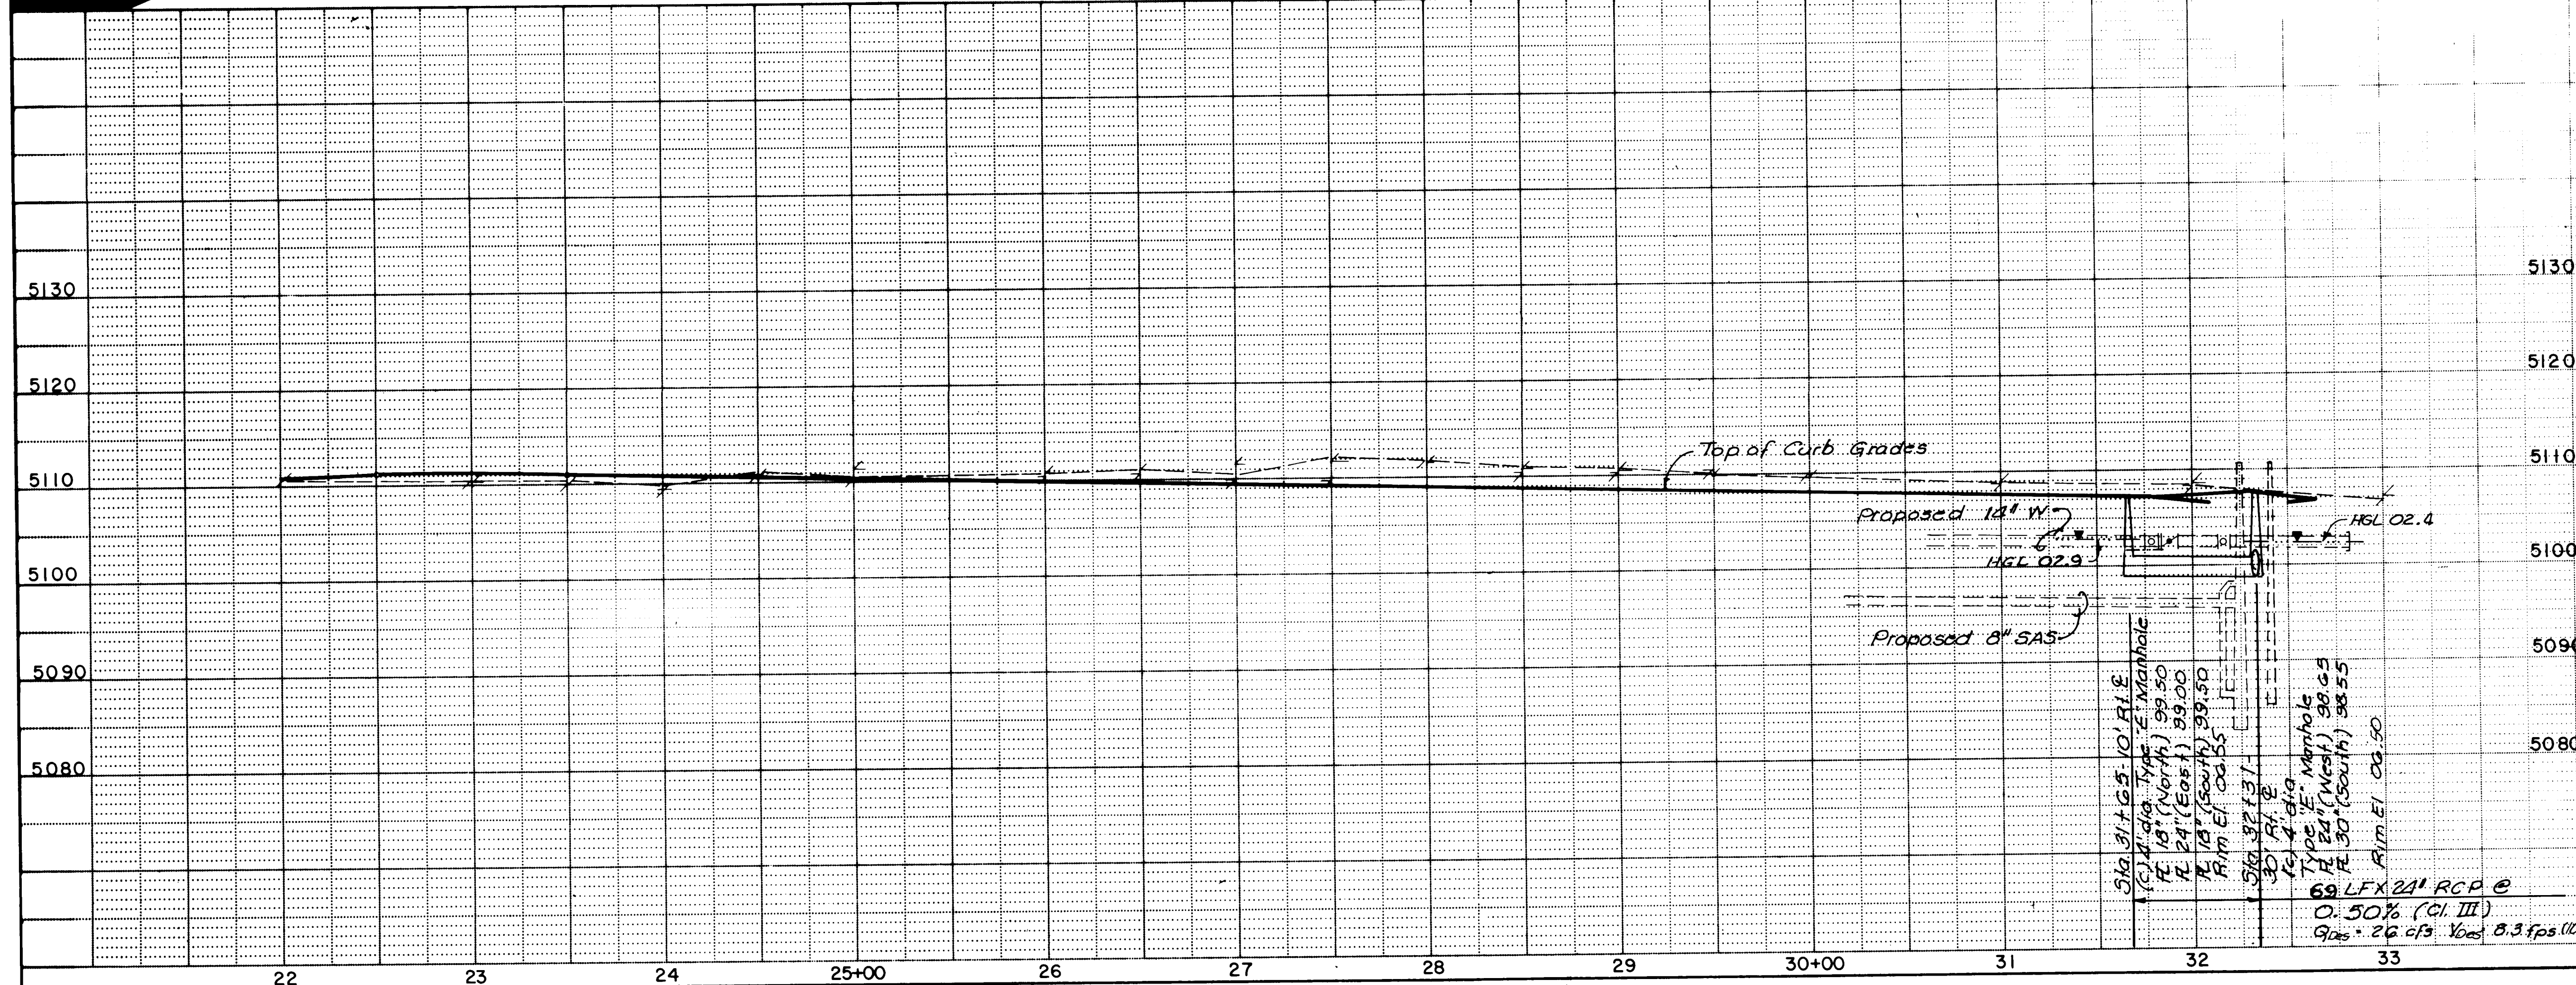

Sta. 31+65 - 20' Lt. E
(c) Single 'C' Inlet
TC Elev. 07.02
Inv. In 02.00
Inv. Out 01.50
R 18' (West) 02.00
(1) 1-18" x 28" (South) CI.III
RCP

Sta. 31+42 - 20' Rt. E
(c) Type 'A' Inlet
TC Elev. 07.13
Inv. Out 02.25
R 18" (East) 02.00
(1) 1-18" x 20" (East) CI.III
RCP

Sta. 31+65 - 10' Rt. E
(c) 4' dia. Type 'E' Manhole
R 18" (North) 99.50
R 24" (East) 99.00
R 18" (South) 99.50
Rim El. 06.55
(1) 1-24" x 65" (East)
RCP CI.III

Sta. 31+65 - 10' Rt. E
(c) Single 'C' Inlet
TC Elev. 07.02
Inv. In 02.00
Inv. Out 01.00 (North)
R 18" (West) 02.00
(1) 1-18" x 8" (North)
RCP CI.III

Sta. 32+31 - 30' Rt. E
(c) 4' dia. Type 'E' Manhole
R 24" (West) 98.65
R 30" (South) 98.55
Rim El. 06.50
(1) 1-30" x 350" (South) CI.III
RCP

STORM DRAIN

CITY OF ALBUQUERQUE
PUBLIC WORKS DEPARTMENT
SPECIAL ASSESSMENT DISTRICT NO. 218



JUNIPER ROAD

APPROVALS	ENGINEER	DATE	APPROVALS	ENGINEER	DATE
City Engineer	Rogers	3/4/89	Liquid Waste	Rogers	3/6/89
Design	W		Traffic	Rogers	3/4/89
Hydrology	CAM	3-7-89	Water	Rogers	3/6/89

DRAWING NO. 3229 MAP NO. H-10 & J-10 SHEET 29 OF 52

AS BUILT INFORMATION		BENCH MARKS		SURVEY INFORMATION		ENGINEER'S SEAL	
CONTRACTOR	UNIVERSAL CONSTRUCTION	TBM #4 - Sta. 32+26 - 3' Lt. E	DATE	NO.	BY		REVISIONS
WORK STARTED BY	DMA	DATE	DATE	DATE	DATE		
FIELD ACCEPTANCE BY	R. HANLEY	DATE	DATE	DATE	DATE		
FIELD CORRECTION BY	DMA	DATE	DATE	DATE	DATE		
MICRO-FILM INFORMATION		RECORDED BY		NO.		DATE	

Note: The existing power pole is to remain at 72nd and Juniper. The Contractor is to install a riser on existing pole. See Sheet 32 for Detail.

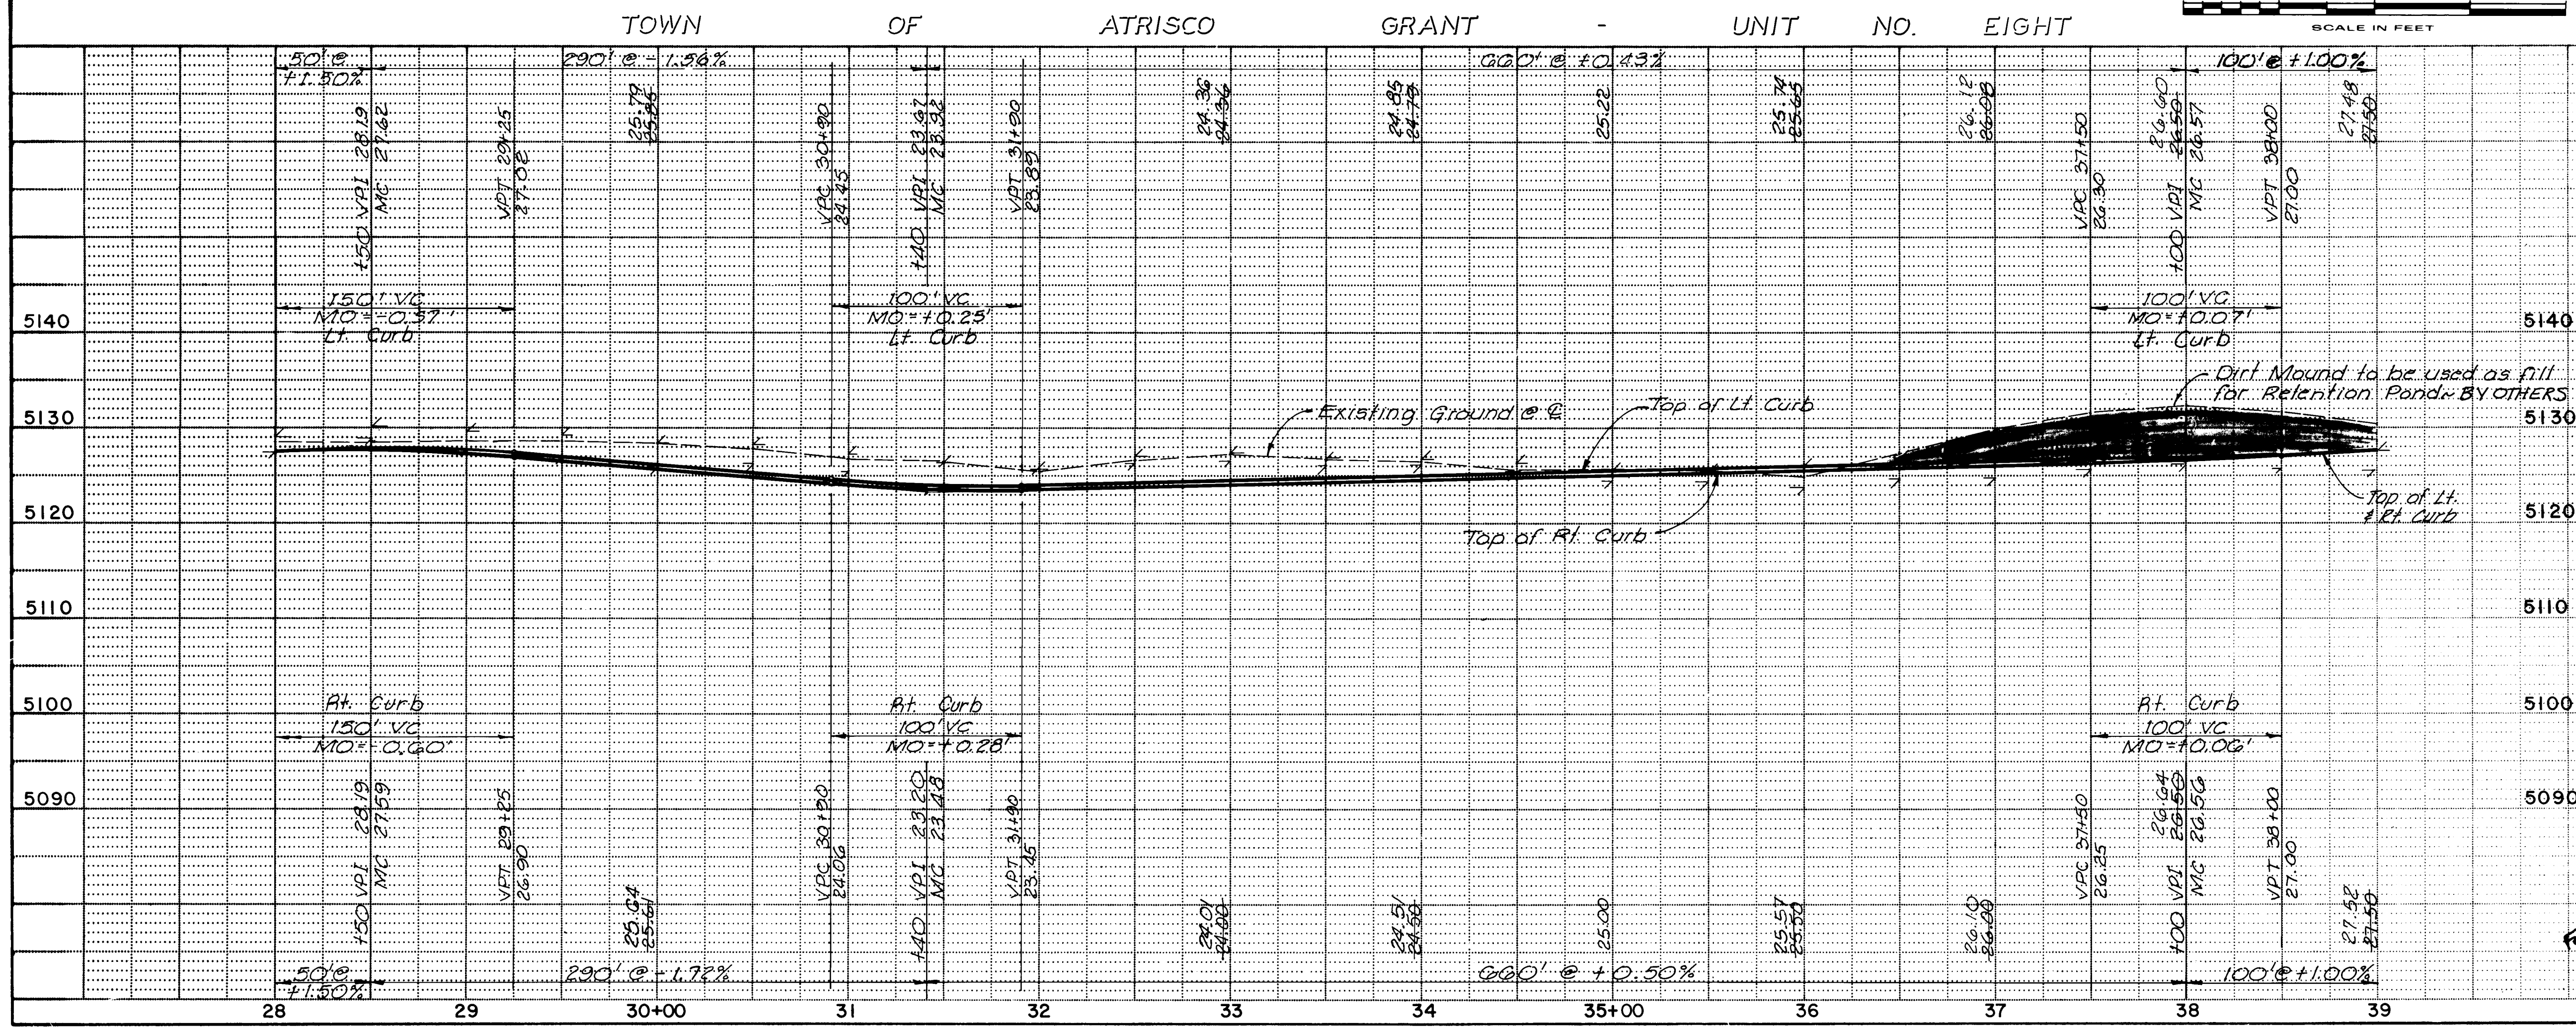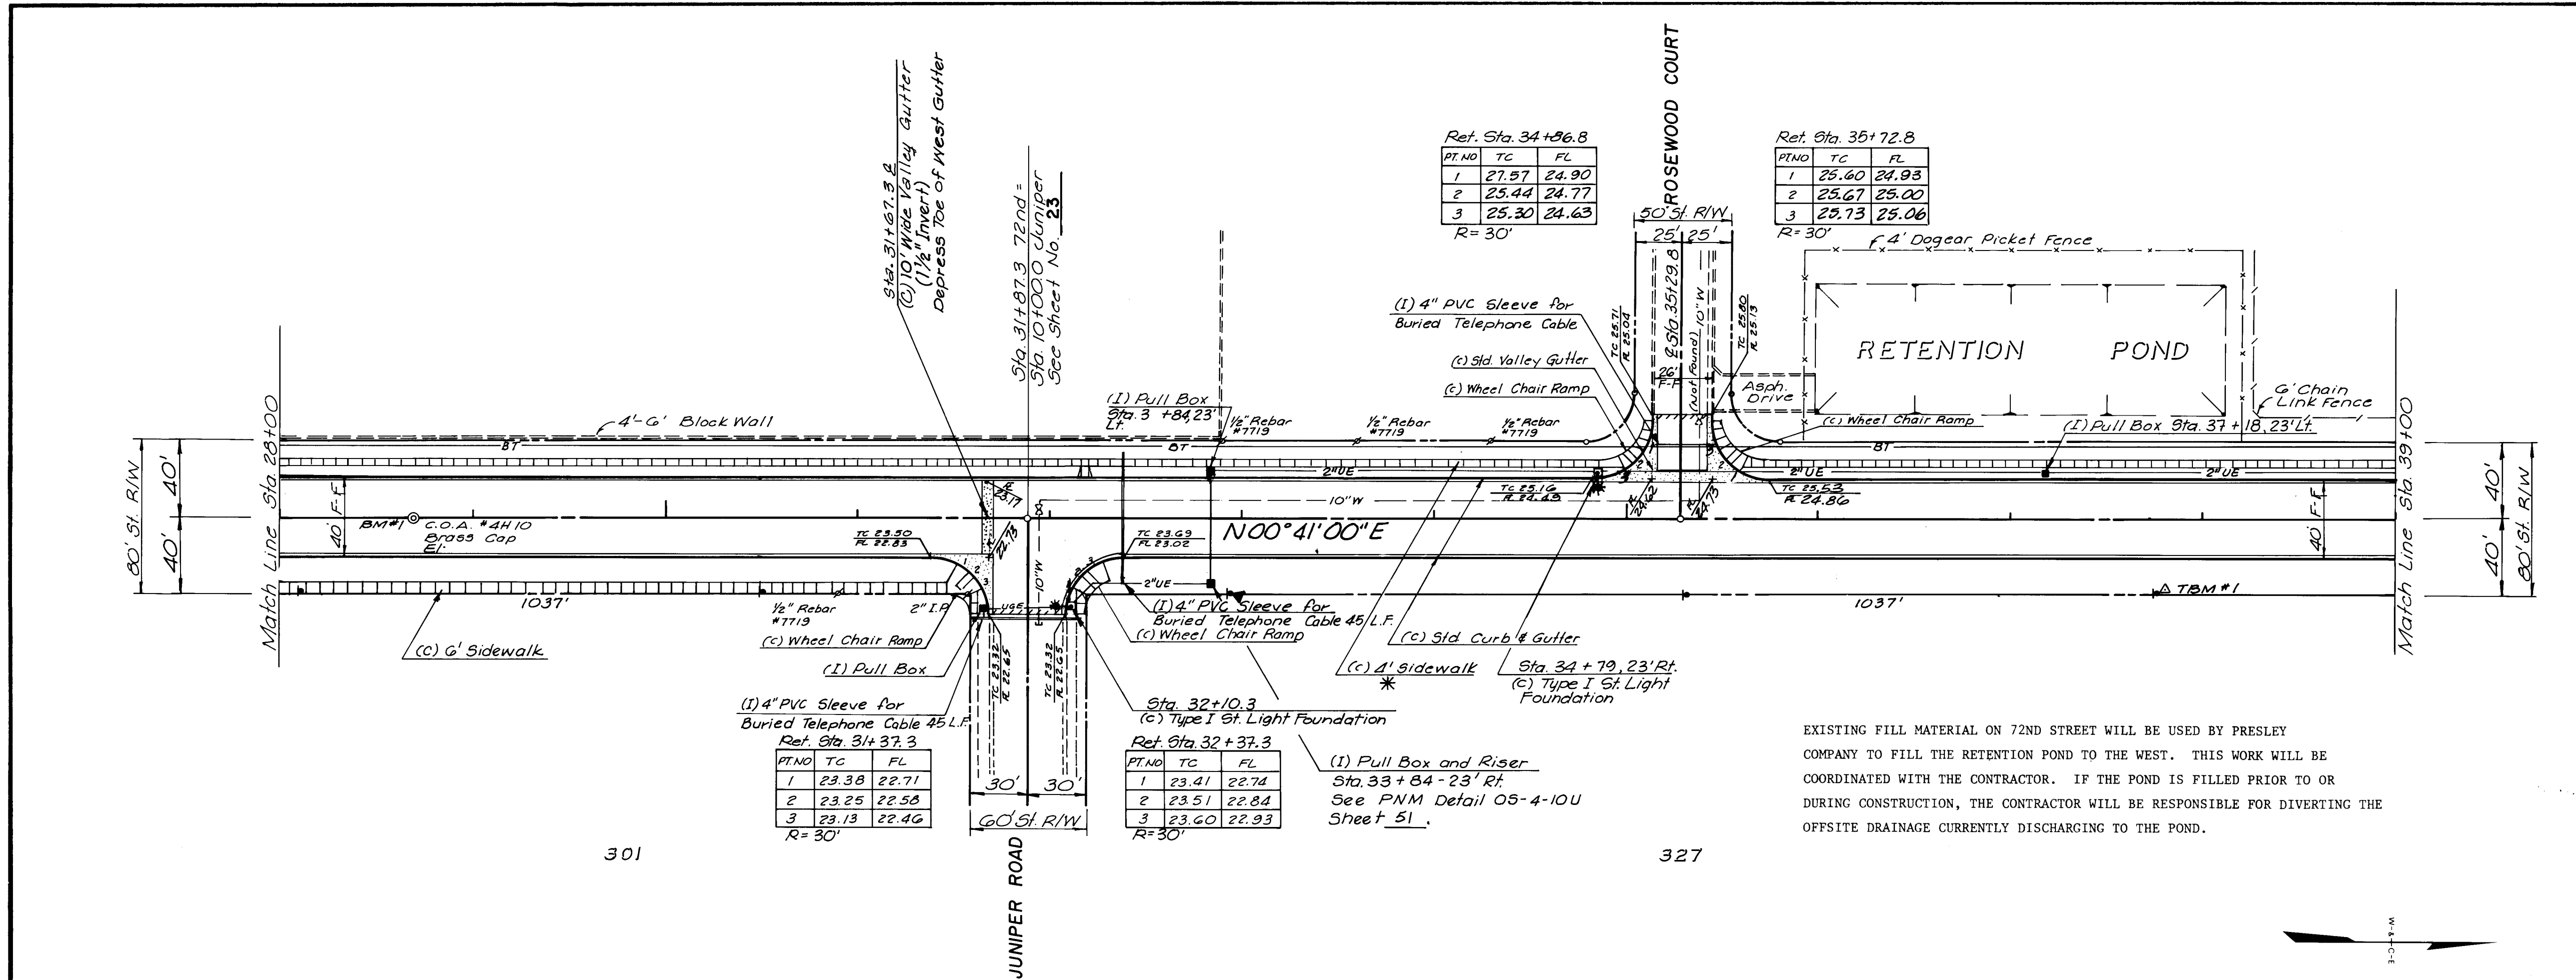




1	2	3	4	5	6	7	8	9	10	11	12
2	6	3	2	2	9	3	1	9	0		

PAVING

CITY OF ALBUQUERQUE PUBLIC WORKS DEPARTMENT SPECIAL ASSESSMENT DISTRICT NO. 218					
72 nd STREET					
APPROVALS	ENGINEER	DATE	APPROVALS	ENGINEER	DATE
City Engineer	Rog. A. Rios	3-14-89	Liquid Waste	1550	3/6/89
AGE - Design			Traffic		
AGE - Hydrology	L.A.M.	3-7-89	Water	1550	3/6/89

DRAWING NO.	3229	MAP NO.	H-10 & J-10	SHEET	31 OF 52
-------------	------	---------	-------------	-------	----------

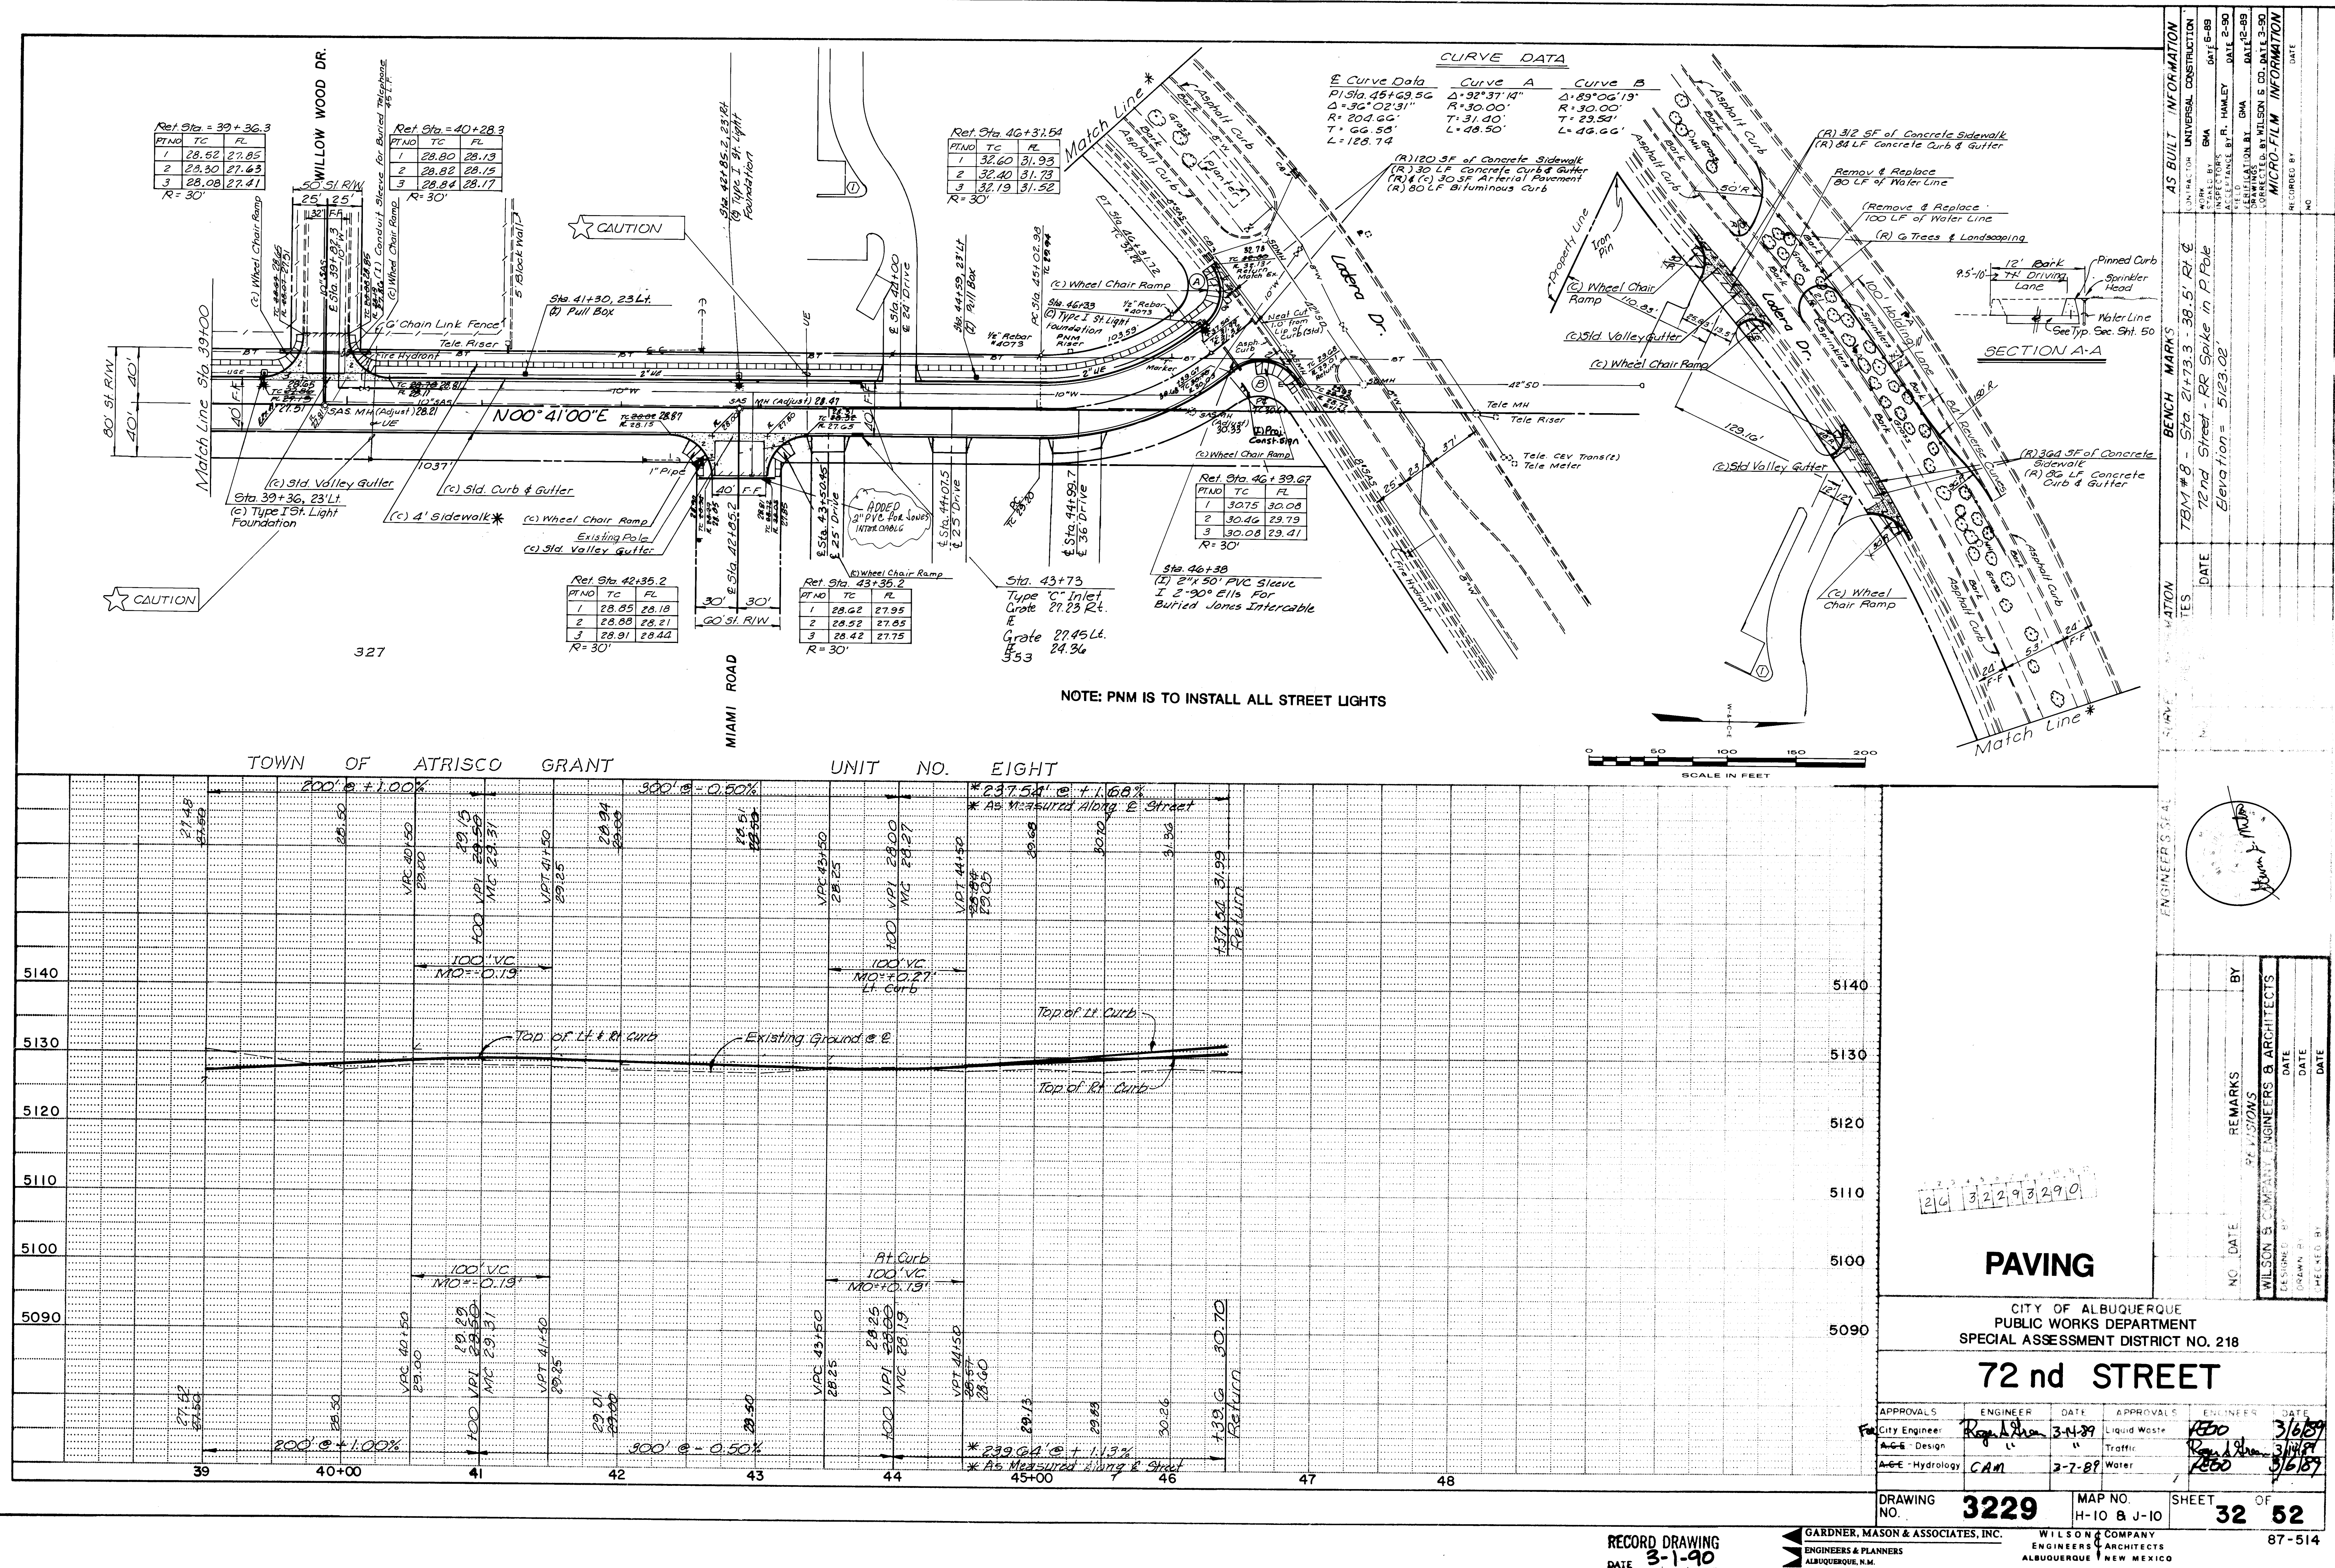

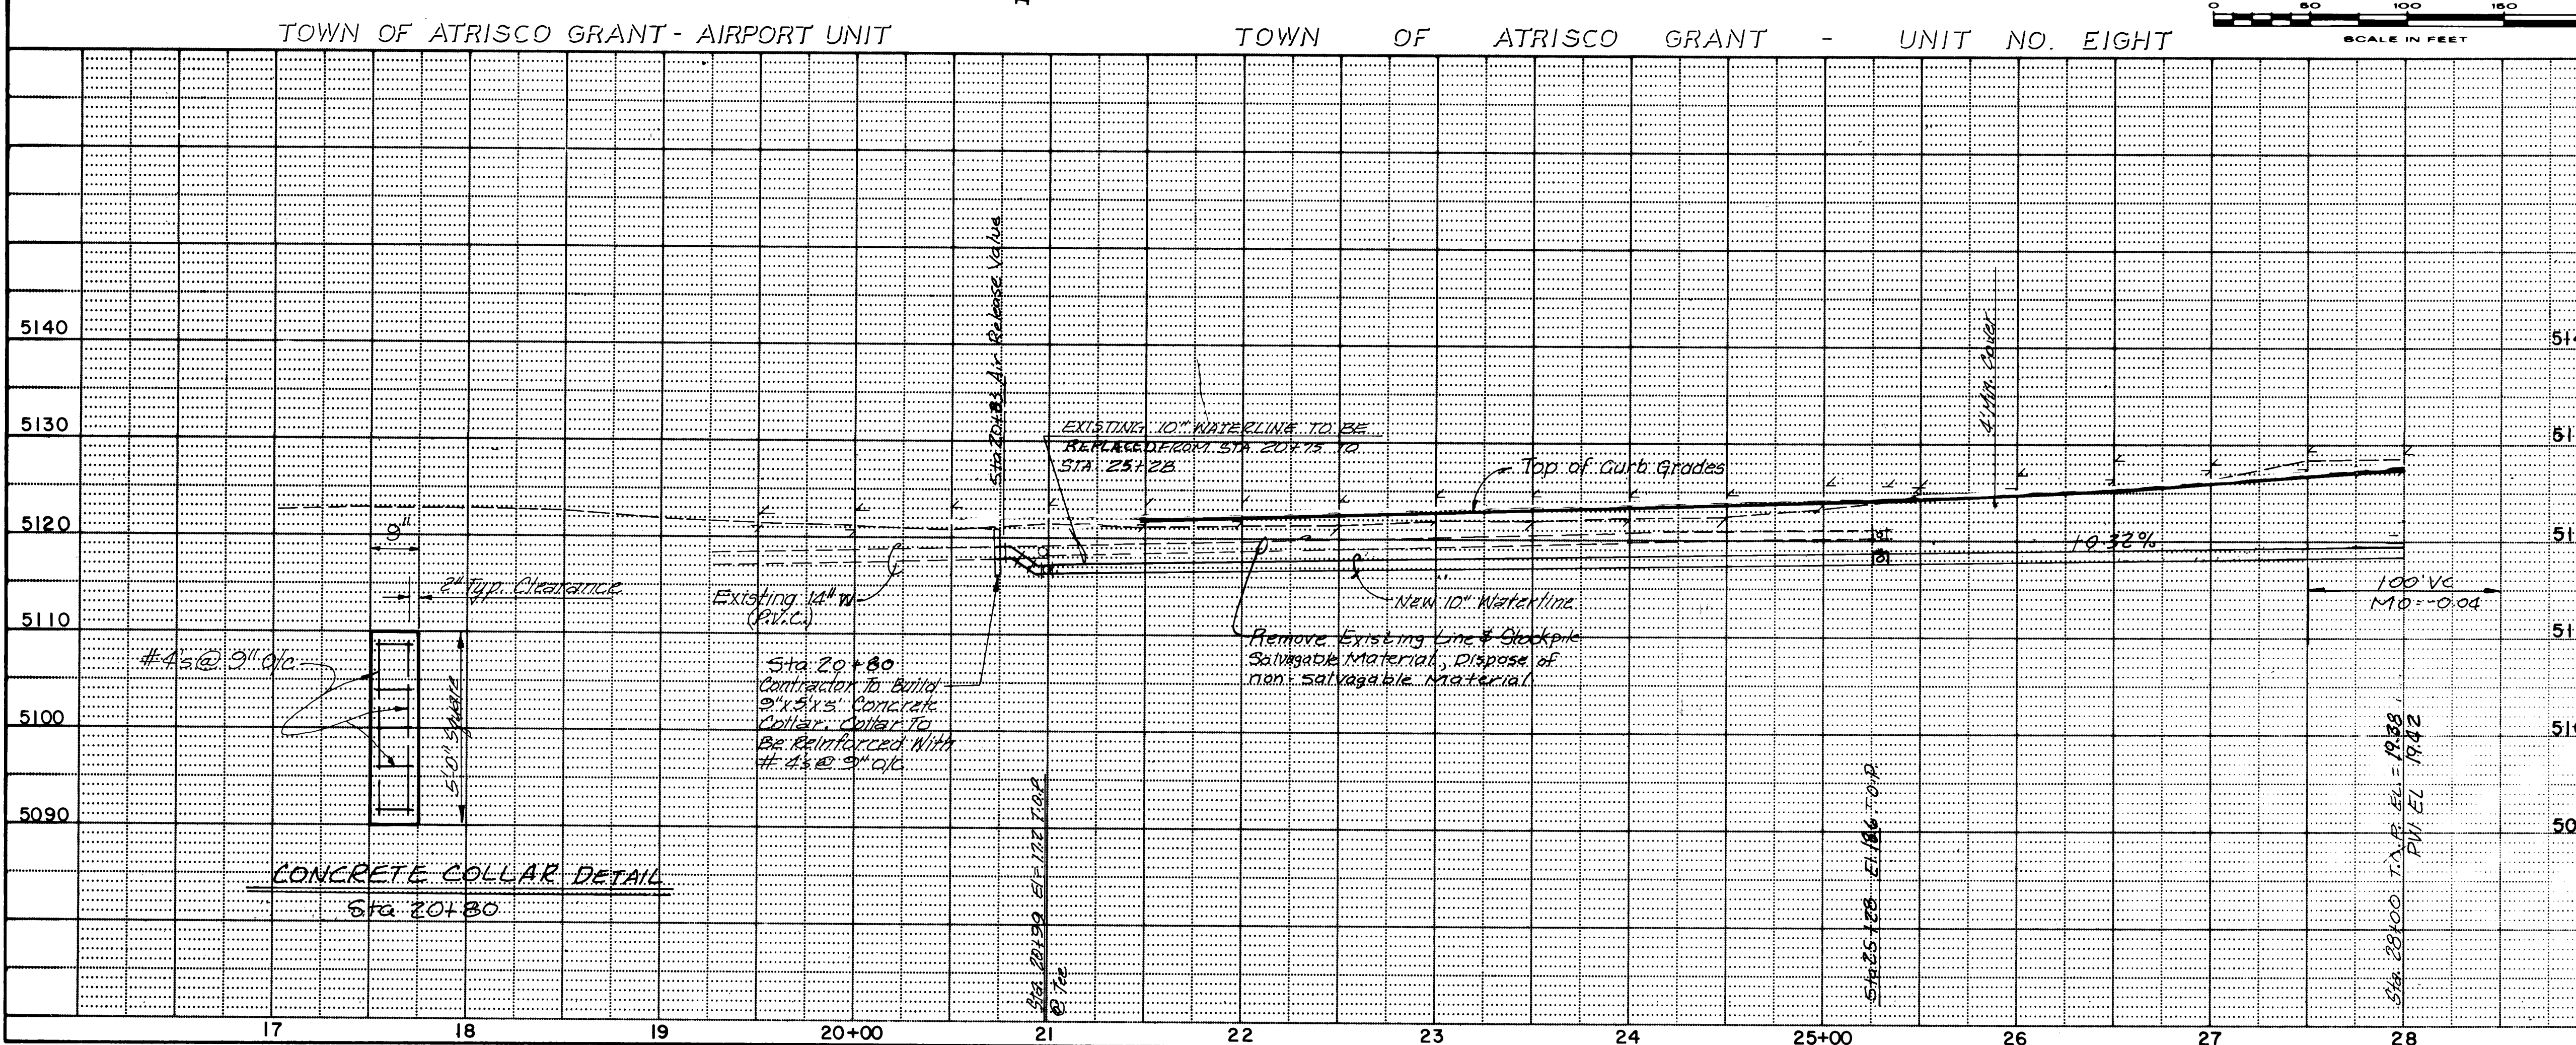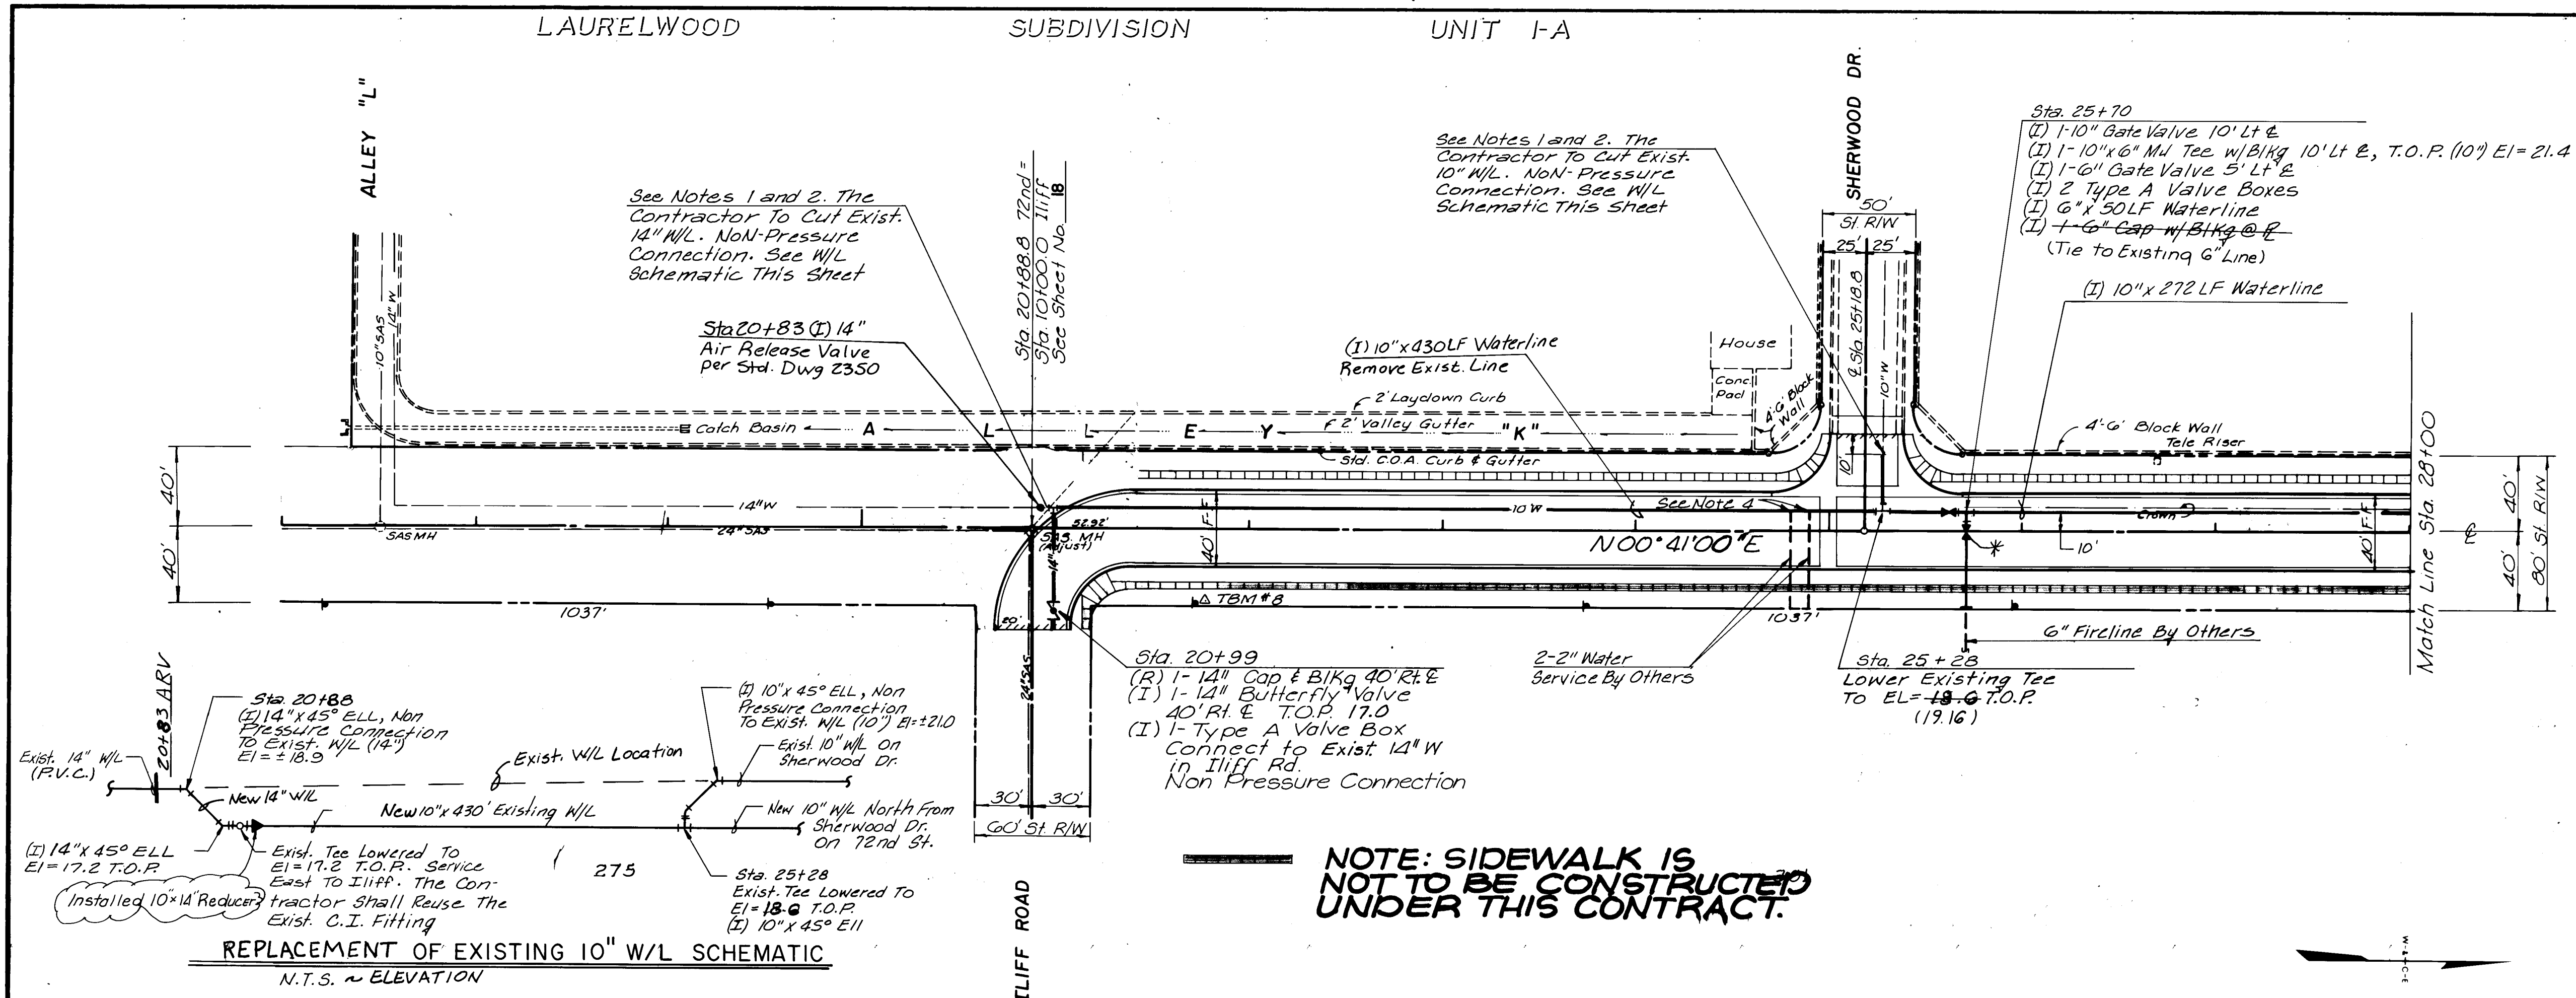

NOTES:

- Before Start of W/L Removal & Replacement The Contractor Shall Field Verify Both Vertical And Horizontal Of 14" W/L @ Sta. 20+80 And 10" W/L @ Sta. 25+28.
- The Contractor Shall Install Restraint Joints And Appurtenances As Required To Secure New Waterline At Joints.
- The Contractor Shall Use City Of Albuquerque Concrete Block-Ing Design Dwg. 2320 As Required
- The Contractor Shall Connect Existing 2" Water Service. This Work To Be Considered An Incidental Cost To This Project.

* Valve Box to have "FIRE LINE" Stamped on the Cover as Approved by the Engineer. See Sheet 35, Note 1 for Details.

AS BUILT INFORMATION

CONTRACTOR	UNIVERSAL CONSTRUCTION	DATE	BY	DATE	BY	DATE	BY
WILSON & COMPANY <td>ENGINEERS & ARCHITECTS<td>3-14-89</td><td>WILSON</td><td>3-14-89</td><td>WILSON</td><td>3-14-89</td><td>WILSON</td></td>	ENGINEERS & ARCHITECTS <td>3-14-89</td> <td>WILSON</td> <td>3-14-89</td> <td>WILSON</td> <td>3-14-89</td> <td>WILSON</td>	3-14-89	WILSON	3-14-89	WILSON	3-14-89	WILSON

ENGINEER'S SEAL

REVISIONS

NO.	DATE	REMARKS	BY
1	3-14-89	DESIGNED BY	WILSON
2	3-14-89	DRAWN BY	WILSON
3	3-14-89	CHECKED BY	WILSON

WATER

CITY OF ALBUQUERQUE
PUBLIC WORKS DEPARTMENT
SPECIAL ASSESSMENT DISTRICT NO. 218

72 nd STREET

APPROVALS

ENGINEER	DATE	APPROVALS	ENGINEER	DATE
City Engineer	3-14-89	Liquid Waste	WILSON	3-14-89
City Engineer	3-14-89	Traffic	WILSON	3-14-89
City Engineer	3-14-89	Water	WILSON	3-14-89

DRAWING NO. 3229

MAP NO. H-10 & J-10


SHEET 33 OF 52

RECORD DRAWING
DATE 3-1-90

GARDNER, MASON & ASSOCIATES, INC.
ENGINEERS & ARCHITECTS
ALBUQUERQUE, N.M.



WILSON & COMPANY
ENGINEERS & ARCHITECTS
ALBUQUERQUE, N.M.

87-514

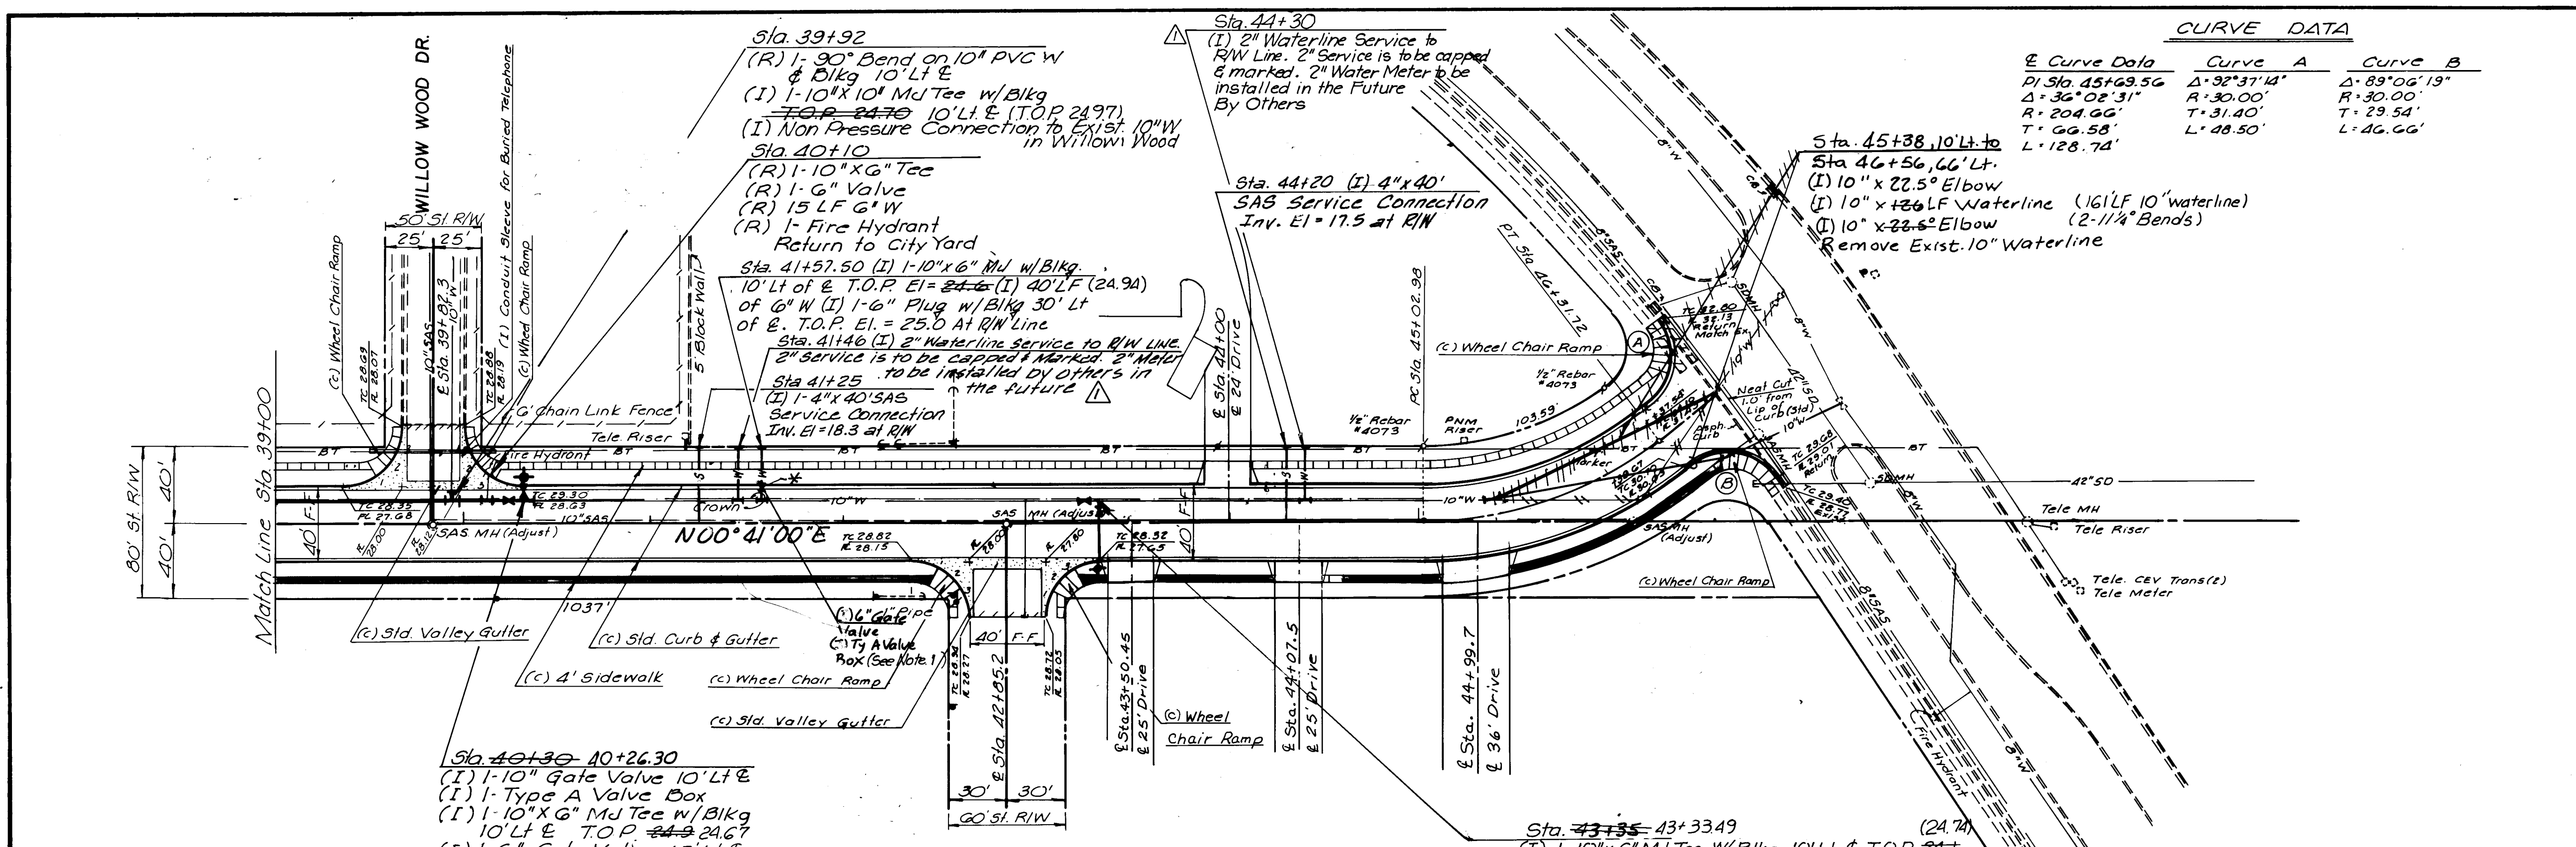

CURVE DATA

Curve Data	Curve A	Curve B
PI Sta 45+69.56	Δ: 92°31'14"	Δ: 89°06'19"
Δ: 36°08'31"	R: 30.00'	R: 30.00'
R: 204.66'	T: 31.40'	T: 29.54'
T: 66.58'	L: 48.50'	L: 46.66'
L: 128.74'		

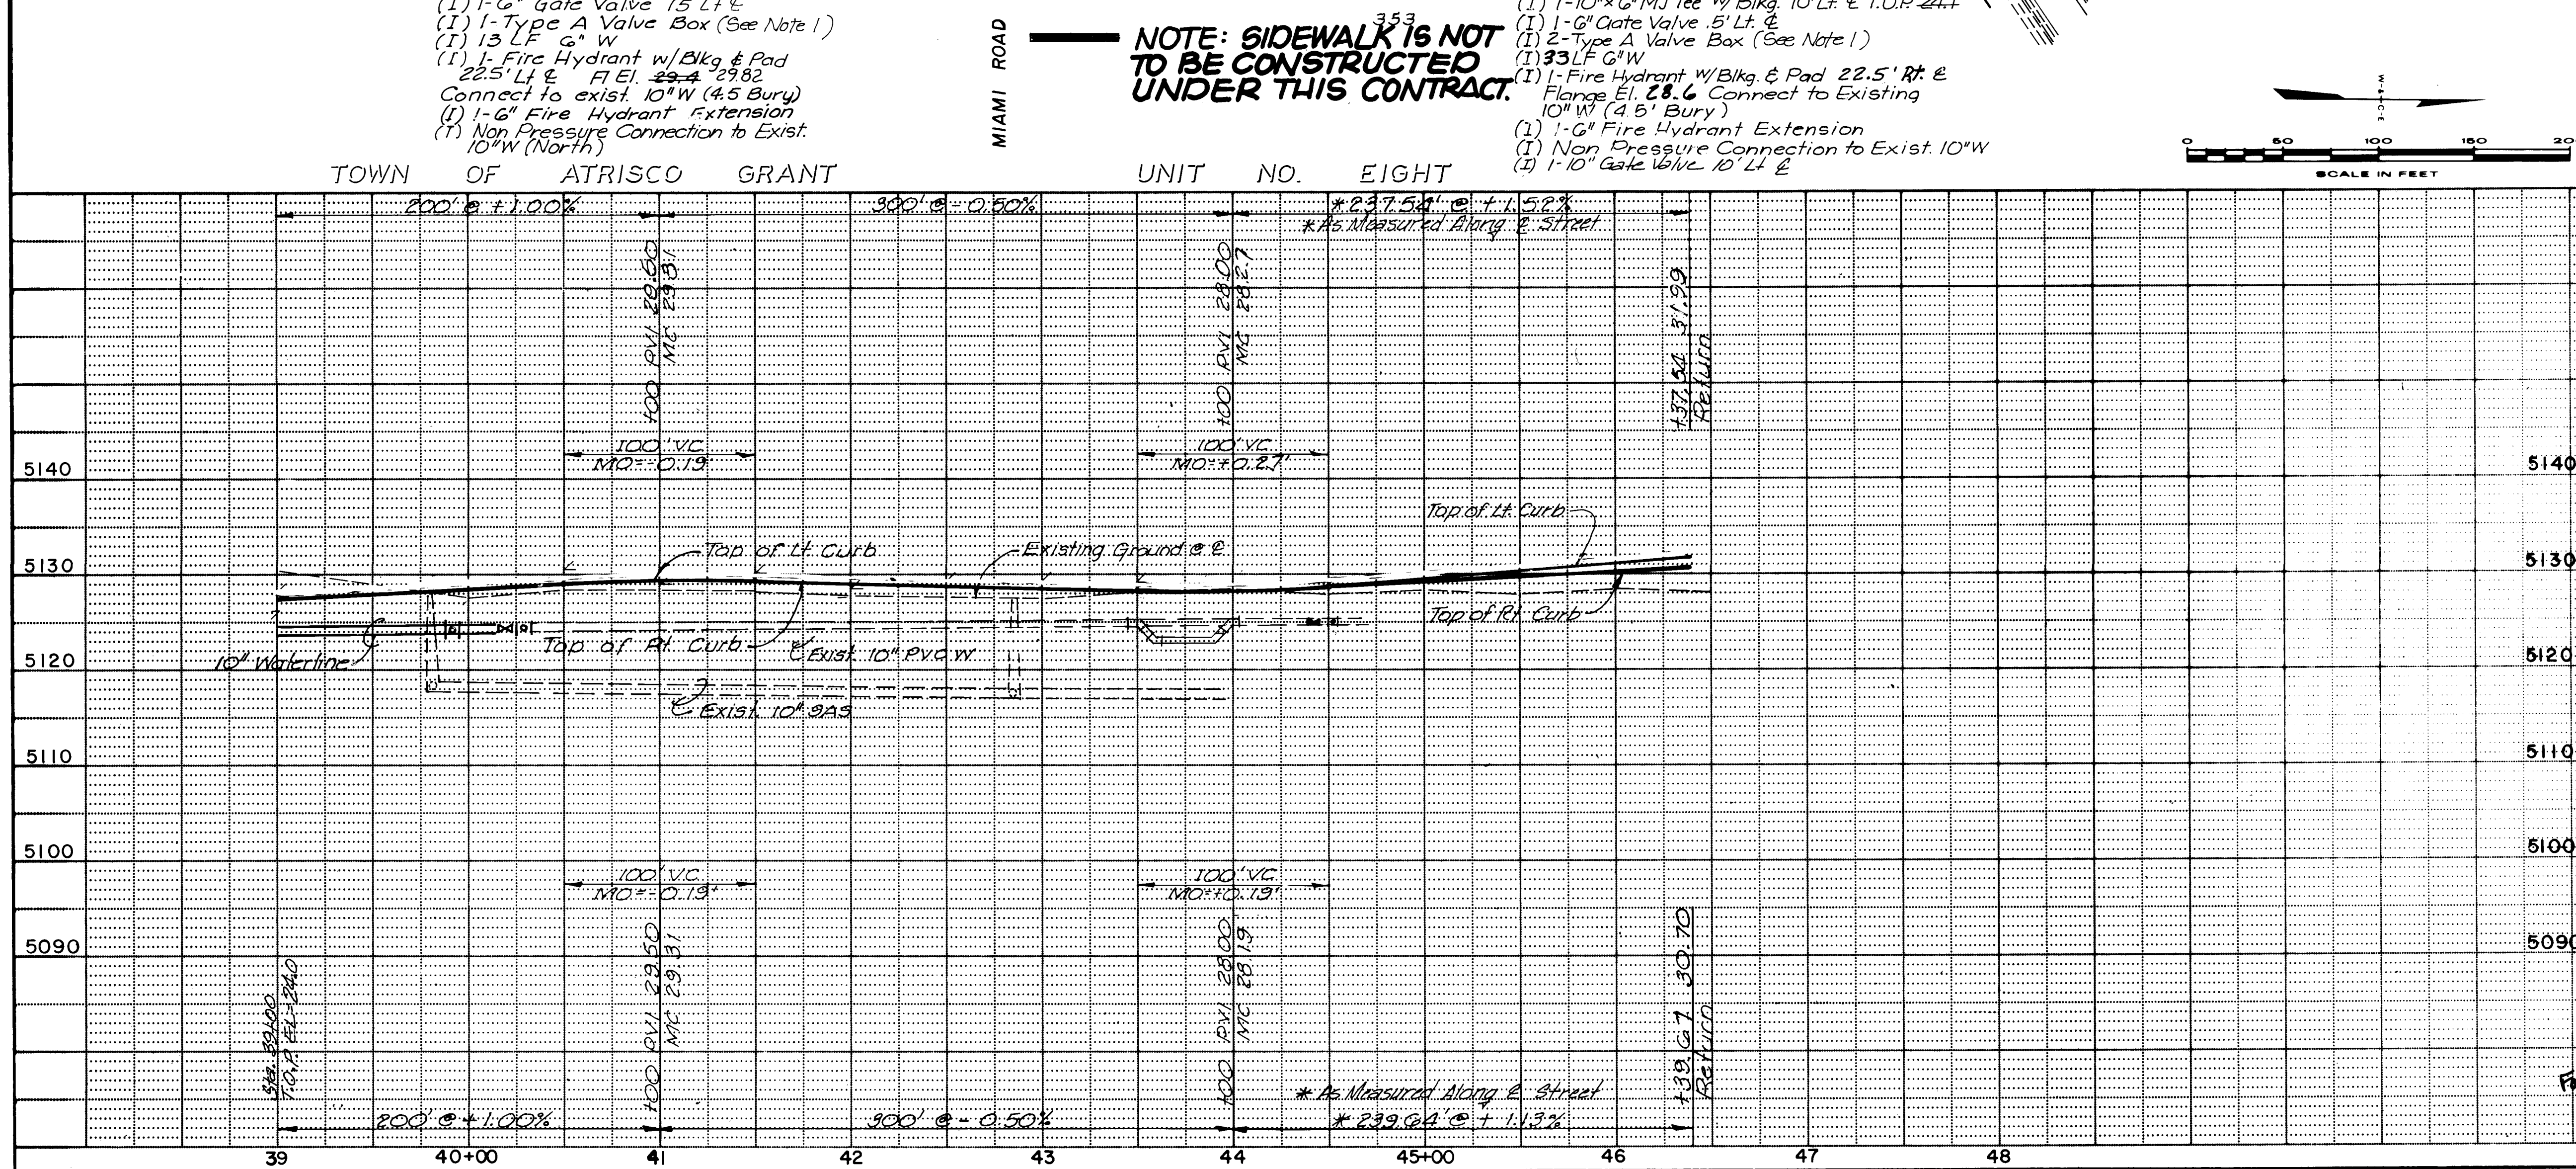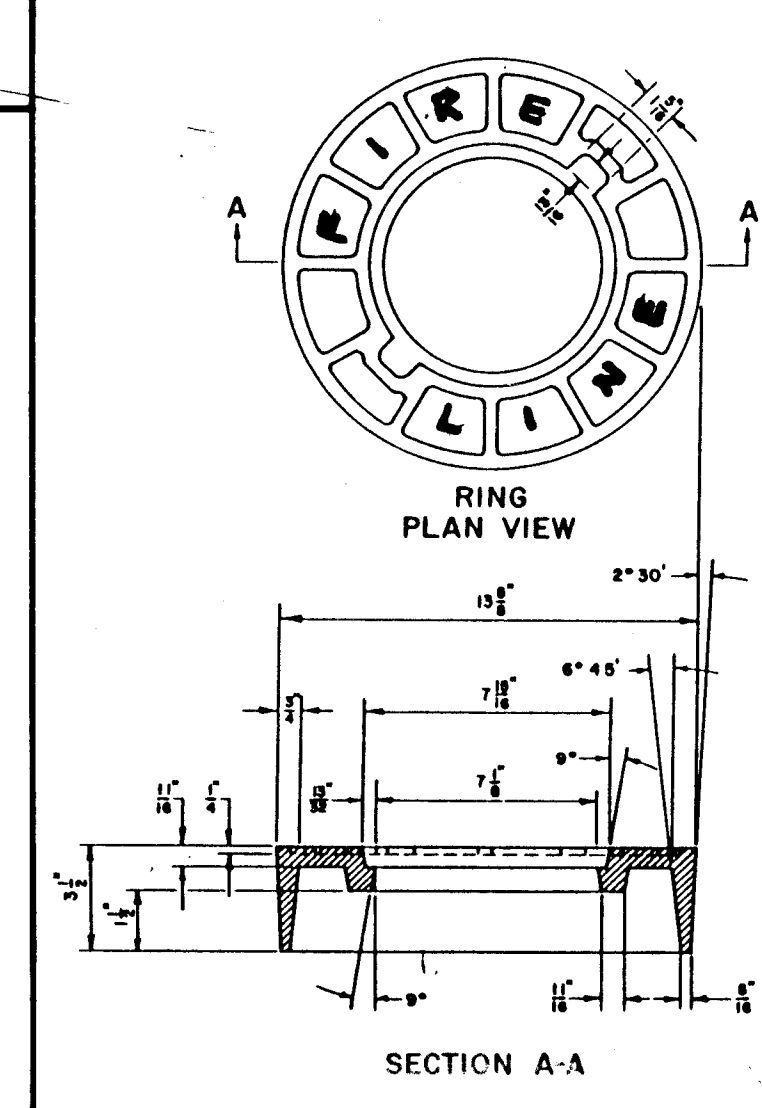

NOTE: VALVE BOX TO HAVE "FIRE LINE" STAMPED ON THE COVER AS APPROVED BY THE ENGINEER.

NOTE: SIDEWALK IS NOT TO BE CONSTRUCTED UNDER THIS CONTRACT.

NOTE: SIDEWALK IS NOT TO BE CONSTRUCTED UNDER THIS CONTRACT.

NOTE: SIDEWALK IS NOT TO BE CONSTRUCTED UNDER THIS CONTRACT.

NOTE: SIDEWALK IS NOT TO BE CONSTRUCTED UNDER THIS CONTRACT.

NOTE: SIDEWALK IS NOT TO BE CONSTRUCTED UNDER THIS CONTRACT.

NOTE: SIDEWALK IS NOT TO BE CONSTRUCTED UNDER THIS CONTRACT.


NOTE: SIDEWALK IS NOT TO BE CONSTRUCTED UNDER THIS CONTRACT.

AS BUILT INFORMATION			BENCH MARKS			SURVEY INFORMATION			ENGINEER'S SEAL		
CONTRACTOR	UNIVERSAL CONSTRUCTION	DATE	DATE	DATE	DATE	NO.	BY	DATE	NO.	BY	DATE
TBM #18	Sta. 21+22	22' R/L									
INSPECTOR	DATE	DATE	DATE	DATE	DATE						
FIELD ENGINEER	DATE	DATE	DATE	DATE	DATE						
VERIFICATION BY	DATE	DATE	DATE	DATE	DATE						
CORRECTED BY	DATE	DATE	DATE	DATE	DATE						
RECORDED BY	DATE	DATE	DATE	DATE	DATE						

REVISIONS			ENGINEER'S SEAL		
NO.	DATE	REMARKS	NO.	BY	DATE
1	10/21/89	Revised Waterline Service			
2					
3					
4					
5					
6					
7					
8					
9					
10					

APPROVALS			ENGINEER			DATE		
City Engineer	Engineer	Date	City Engineer	Engineer	Date			
City Engineer	Engineer	3-1-90	City Engineer	Engineer	3-1-90			
A-E-E-Design	Engineer	3-1-90	A-E-E-Design	Engineer	3-1-90			
A-E-E-Hydrology	Engineer	3-1-90	A-E-E-Hydrology	Engineer	3-1-90			

DRAWING NO.			MAP NO.			SHEET		
3229	H-10 & J-10	35	3229	H-10 & J-10	35			
3229	H-10 & J-10	35	3229	H-10 & J-10	35			

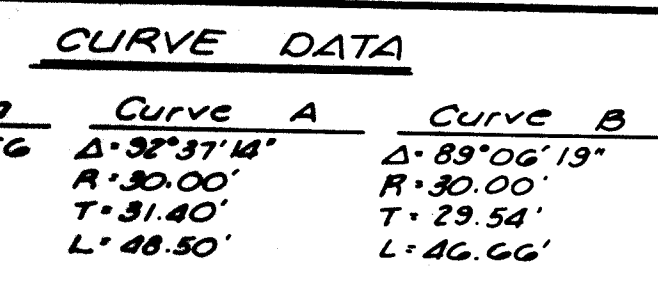A circular professional engineer seal for Steven J. Metro, No. 8220, State of New Mexico. The seal features the text "STEVEN J. METRO" at the top, "NEW MEXICO" on the left, "PROFESSIONAL ENGINEER" on the right, and "REGISTERED" at the bottom. The number "8220" is in the center. A signature is written across the seal.

DRAWING NO.	3229	MAP NO. H-10 & J-10	SHEET 36 OF 52
-------------	------	------------------------	----------------

NOTE
See Sheet No. 49 for Details
of Drainage Storage Ponds.

PT.	NO.	TC	FL
1	06.49	05.82	
2	06.60	05.93	
3	06.43	05.76	

R = 70'
 $\Delta = 89^{\circ}56'15''$

PT.	NO.	TC	FL
3	06.32	05.7	
2	06.42	05.75	
1	06.35	05.71	


R = 30'
 $\Delta = 89^{\circ}56'15''$

Curve A
R = 70'
D = $81^{\circ}51'04''$
 $\Delta = 90^{\circ}$
L = 109.9'

(c) Wheel Chair Ramp
Sta. 10+50, 23' Lt.
(c) Type I St. Light Foundation
(1) Pull Box Sta. 12+90, 23' Lt.
Match Line Sta. 20+65.78 Iliff
See Sheet No. 17 for Iliff
N 00° 41' 00" E
(c) 5' d. Curb & Gutter
(c) 4' sidewalk *
(1) 2" x 50' PVC Sleeve
(1) 2" x 90' EII for Buried Jones Inter-Cable
See Detail on Sht.

TOWN OF ATRISCO GRANT - UNIT NO. EIGHT

SCALE IN FEET
0 50 100 150 200

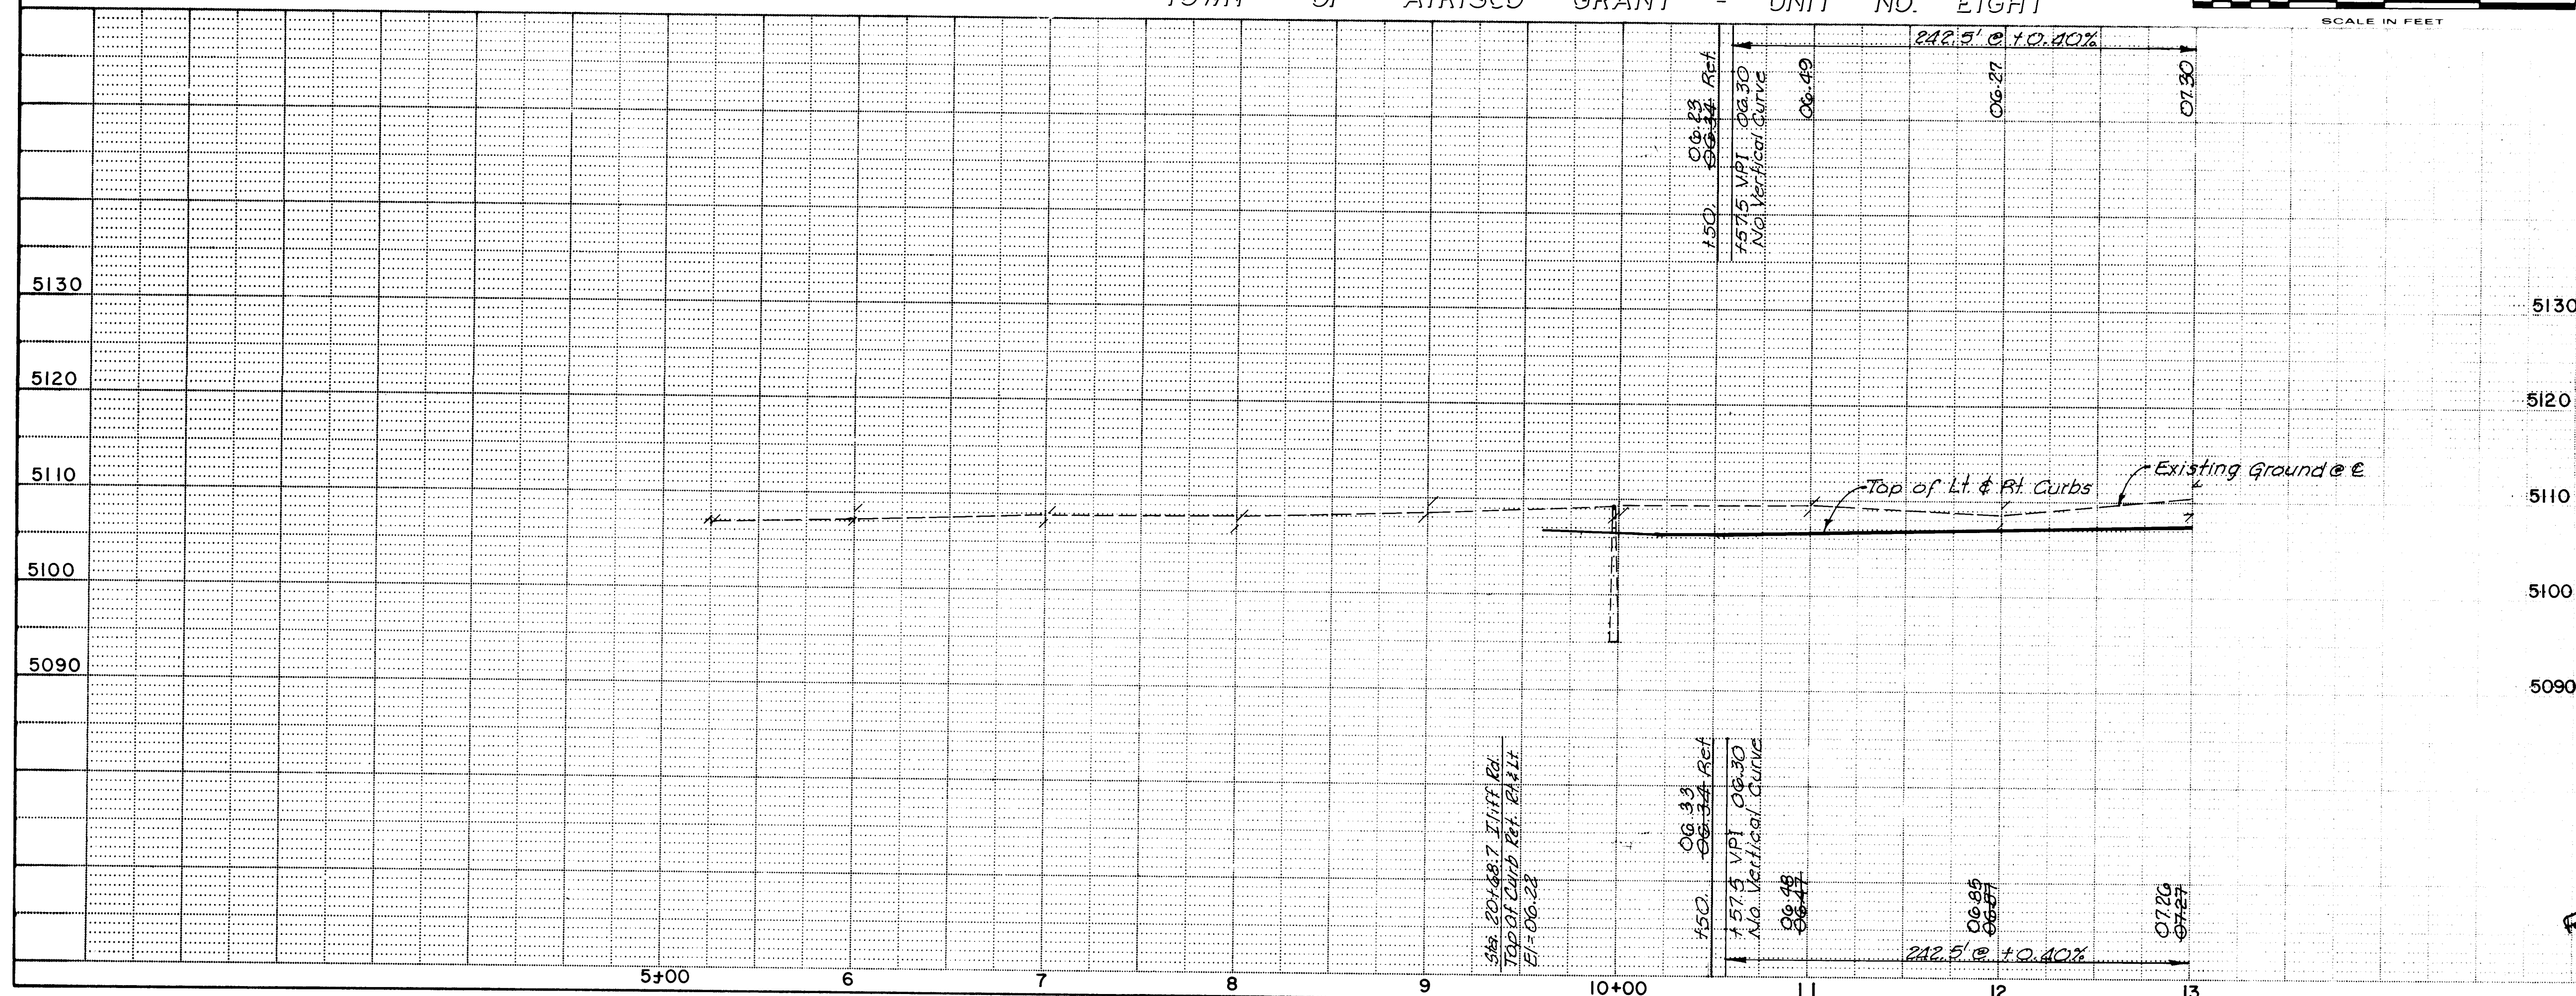

AS BUILT INFORMATION	
UNIVERSAL CONSTRUCTION	DATE 6-89
BY R. HANLEY	DATE 2-90
BY GMA	DATE 12-89
BY WILSON S. CO.	DATE 3-90
MICRO FILM INFORMATION	
RECORDED BY	DATE

NO.	DATE	REMARKS	BY
1			
2			
3			
4			
5			
6			
7			
8			
9			
10			
11			
12			


PAVING

CITY OF ALBUQUERQUE
PUBLIC WORKS DEPARTMENT
SPECIAL ASSESSMENT DISTRICT NO. 218



68th STREET

APPROVALS	ENGINEER	DATE	APPROVALS	ENGINEER	DATE
City Engineer	Reginald Shaw	3-14-89	Liquid Waste	REGO	3/6/89
Design			Traffic	Reginald Shaw	3-14-89
Hydrology	LAM	3-7-89	Water	REGO	3/6/89

DRAWING NO.	3229	MAP NO.	H-10 & J-10	SHEET	37 52
-------------	------	---------	-------------	-------	-------

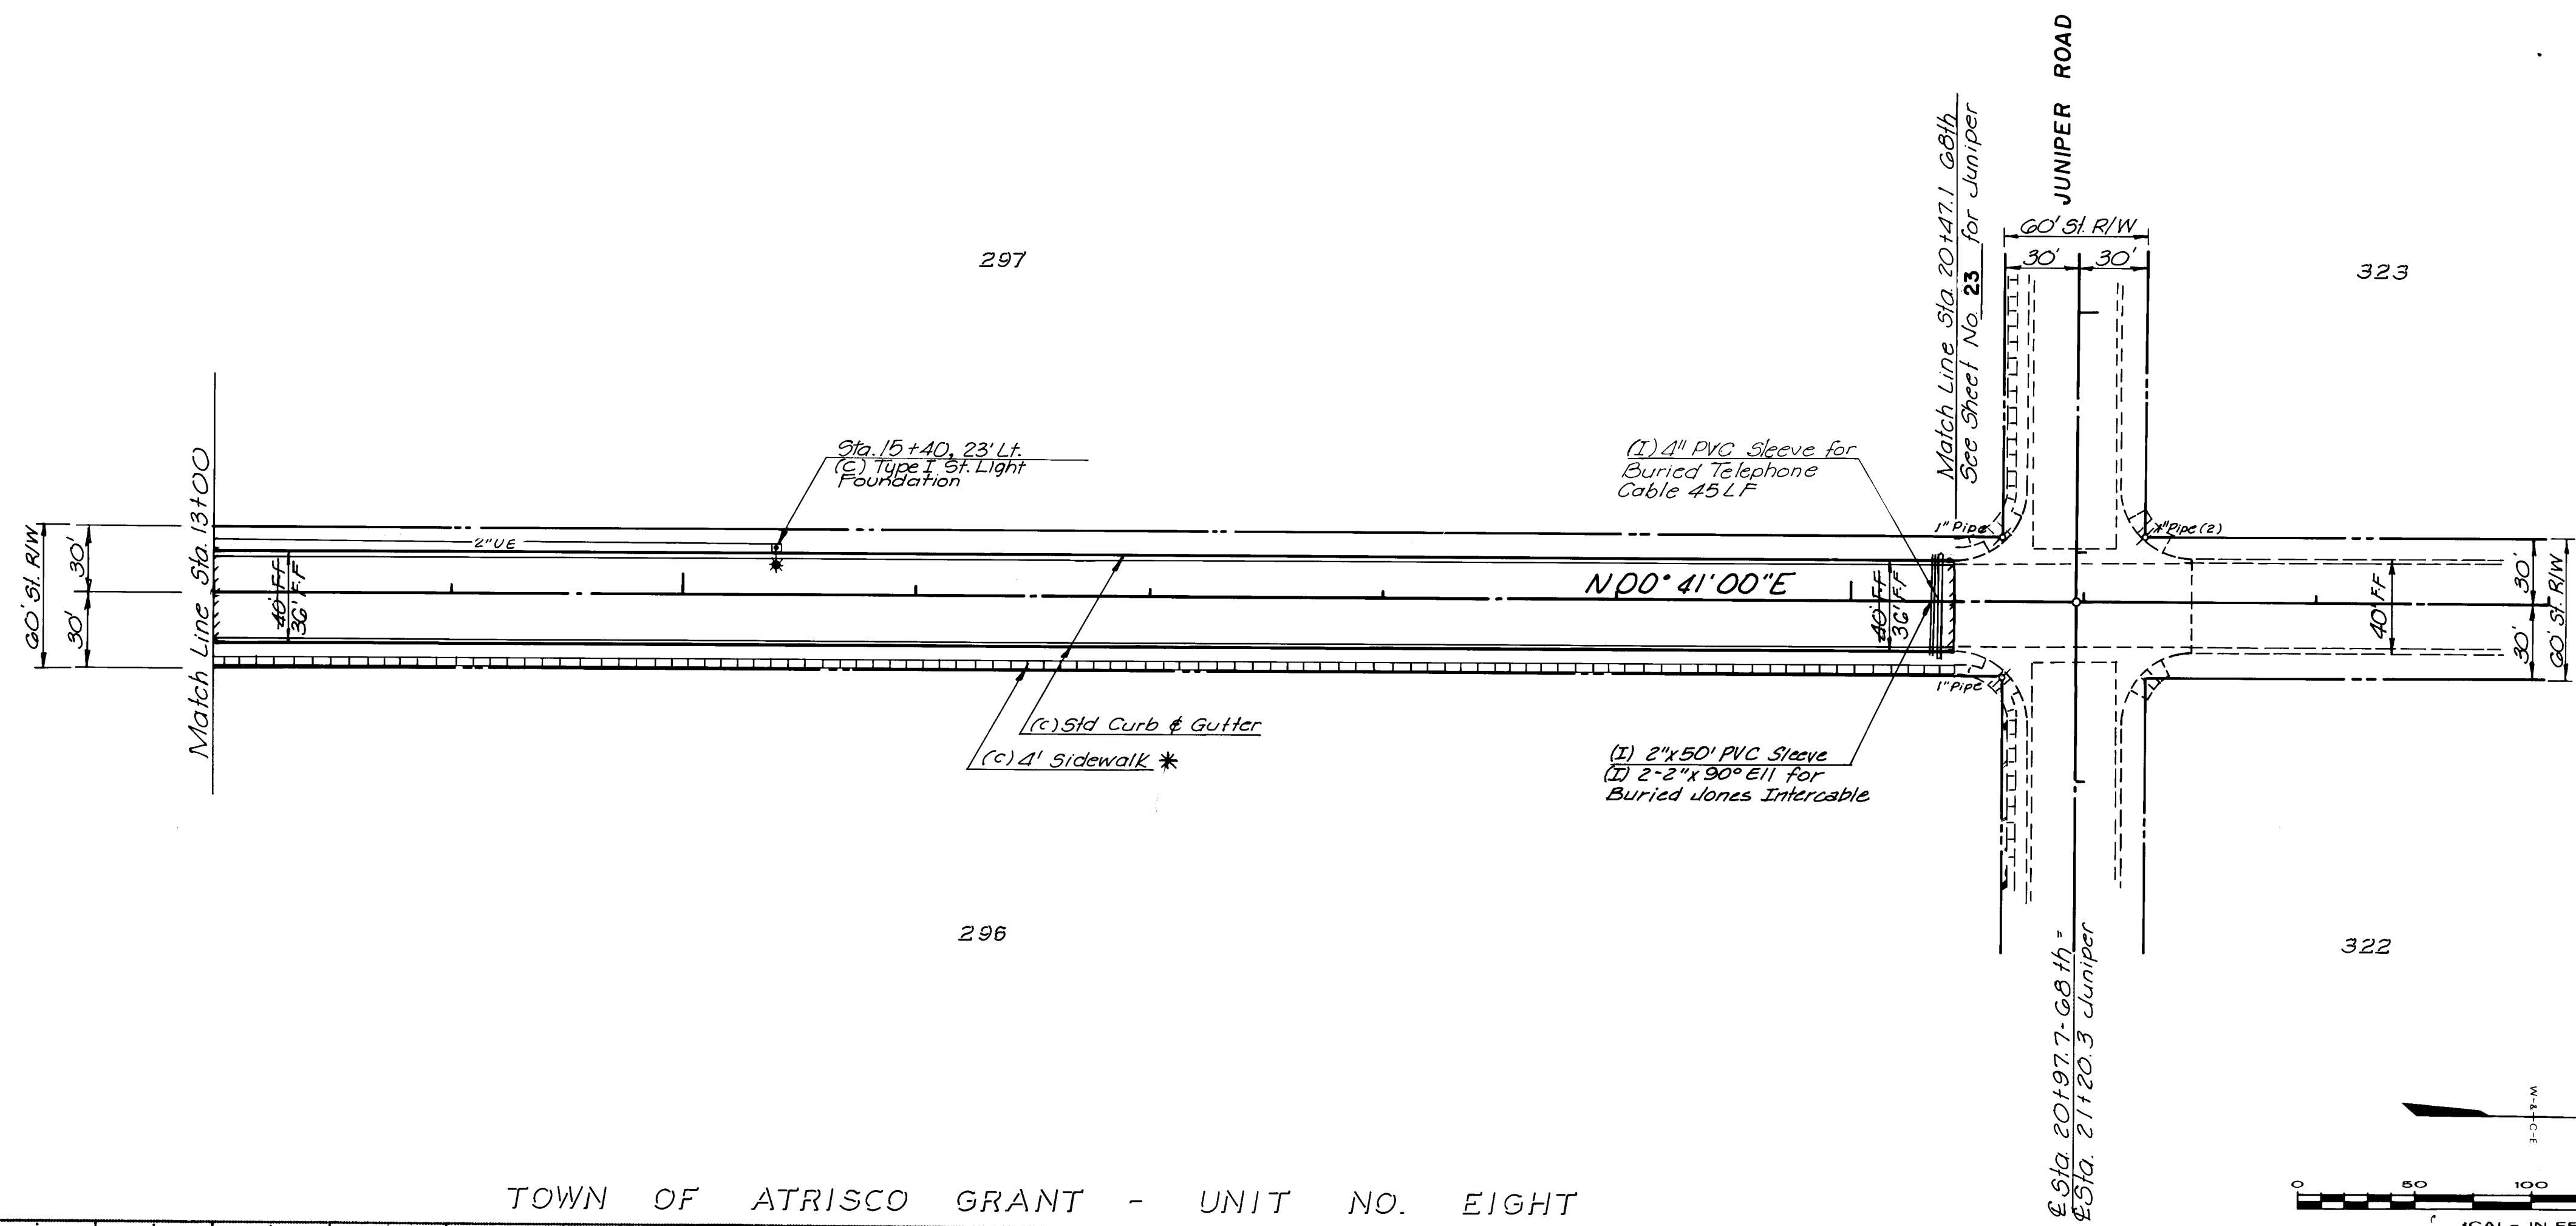

TOWN OF ATRISCO GRANT - UNIT NO. EIGHT

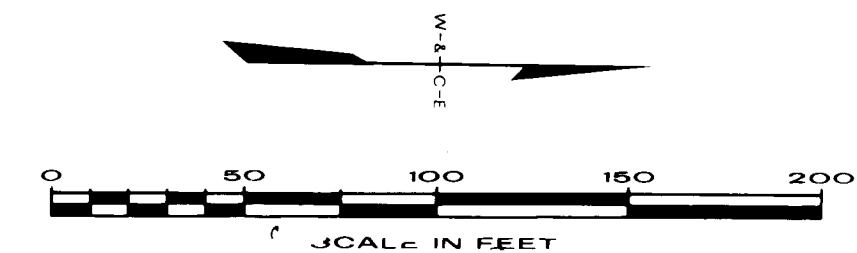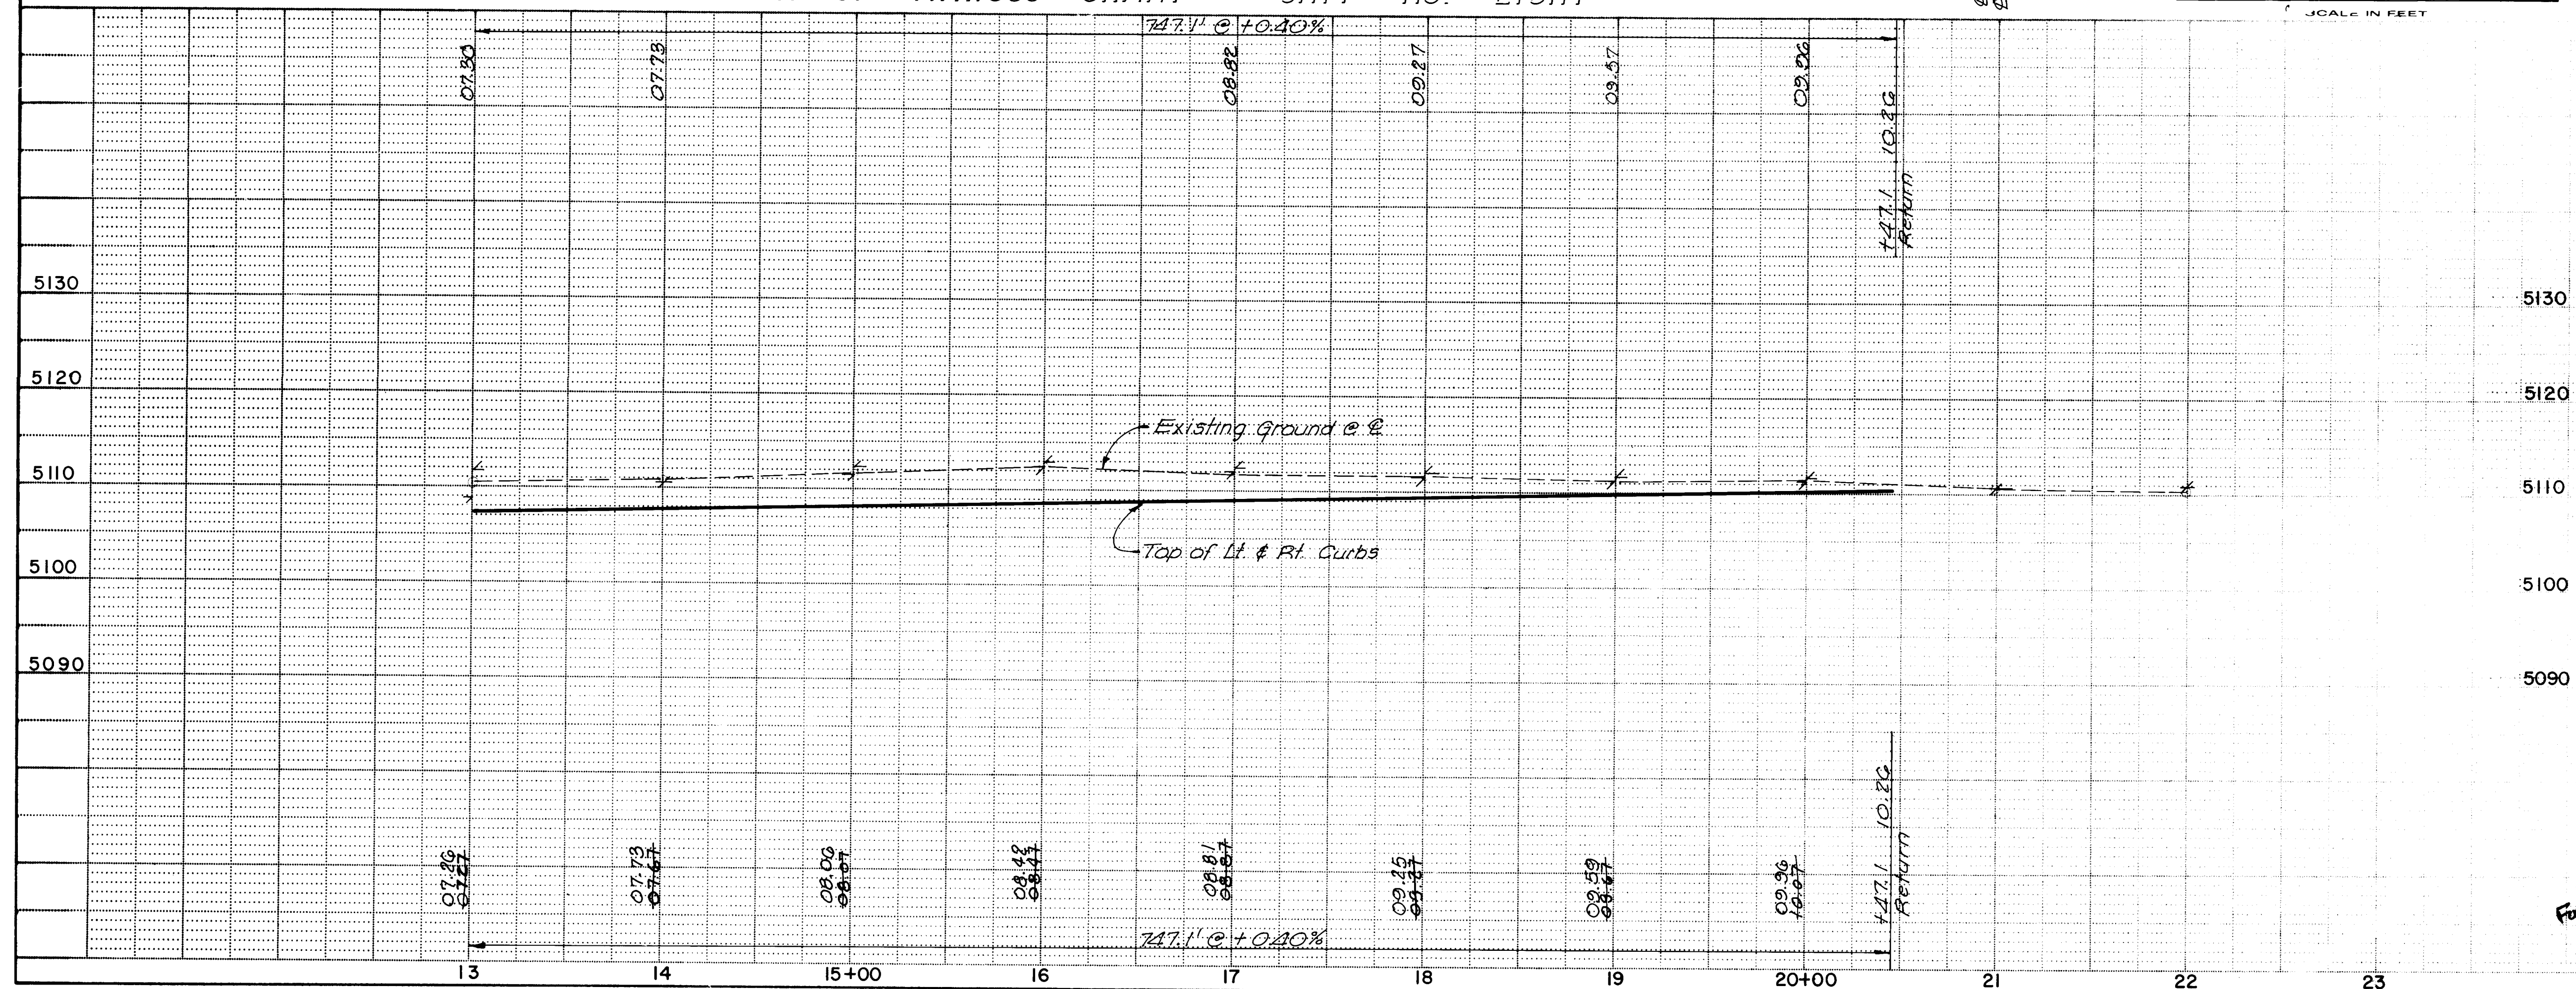

PAVING

CITY OF ALBUQUERQUE
PUBLIC WORKS DEPARTMENT
SPECIAL ASSESSMENT DISTRICT NO. 218

68th STREET


APPROVALS	ENGINEER	DATE	APPROVALS	ENGINEER	DATE
City Engineer	Reginald	3-14-89	City Engineer	Reginald	3-14-89
Design	"	"	Design	"	"
Hydrology	CAM	3-7-89	Hydrology	CAM	3-7-89

DRAWING NO.	MAP NO.	SHEET	OF
3229	H-10 & J-10	38	52



RECORD DRAWING
DATE 3-1-90

GARDNER, MASON & ASSOCIATES, INC.
ENGINEERS & PLANNERS
ALBUQUERQUE, N.M.
WILSON & COMPANY
ENGINEERS & ARCHITECTS
ALBUQUERQUE, NEW MEXICO
87-514

SECTION	DATE	REVISIONS	BY	DATE
TBM #18 - Sta. 21+22.22 RA & IIRF Road - 11 Cut on NW Corner				
Manhole Pad				
Elevation 5109.43				

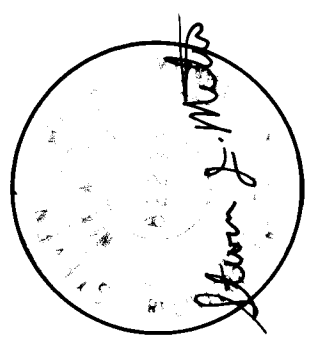


REMARKS	DATE	BY
WILSON & COMPANY ENGINEERS & ARCHITECTS		
DATE		
DATE		
DATE		

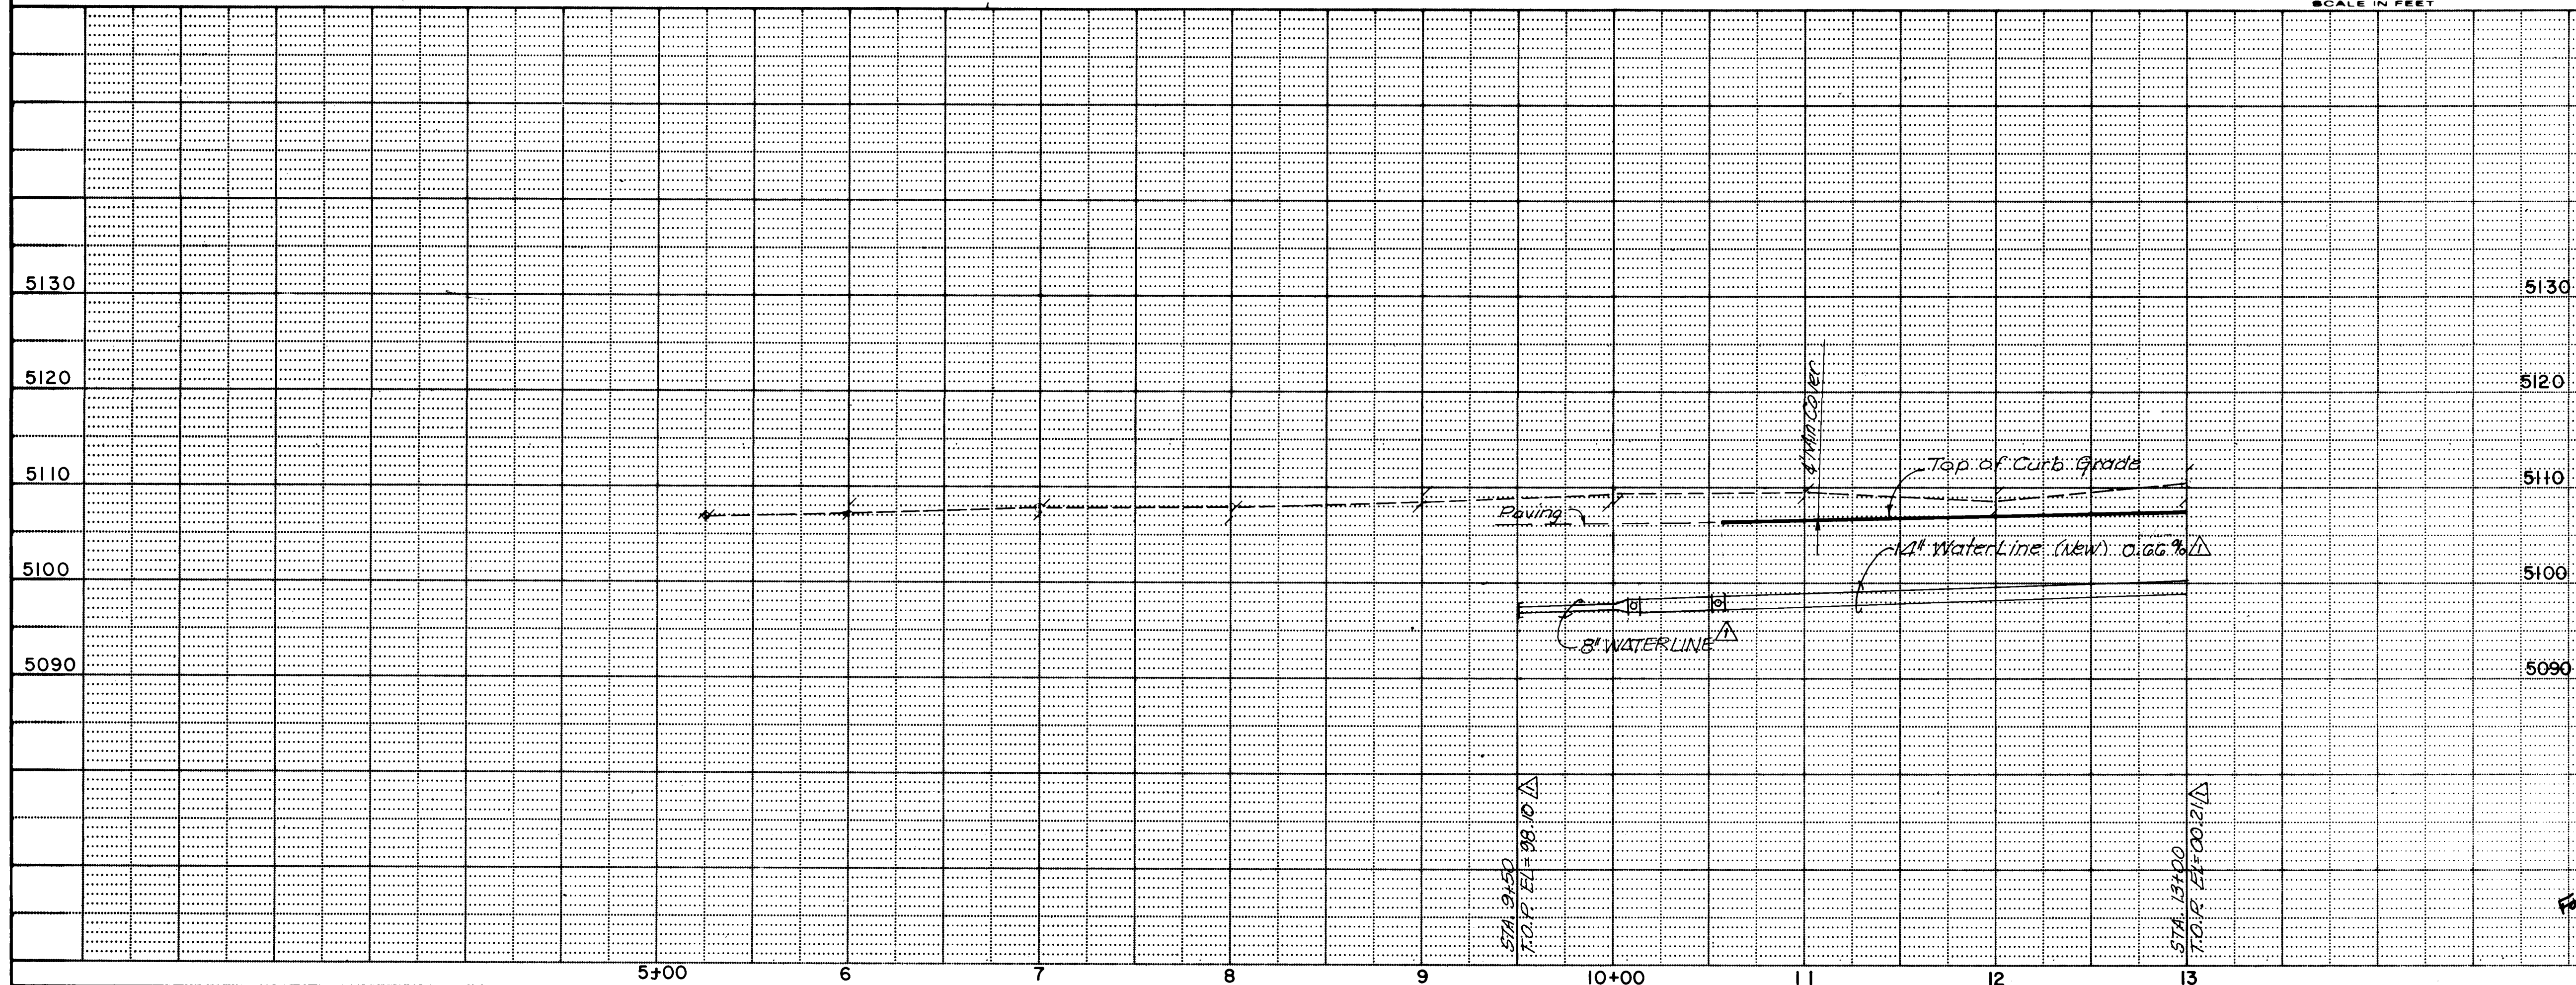
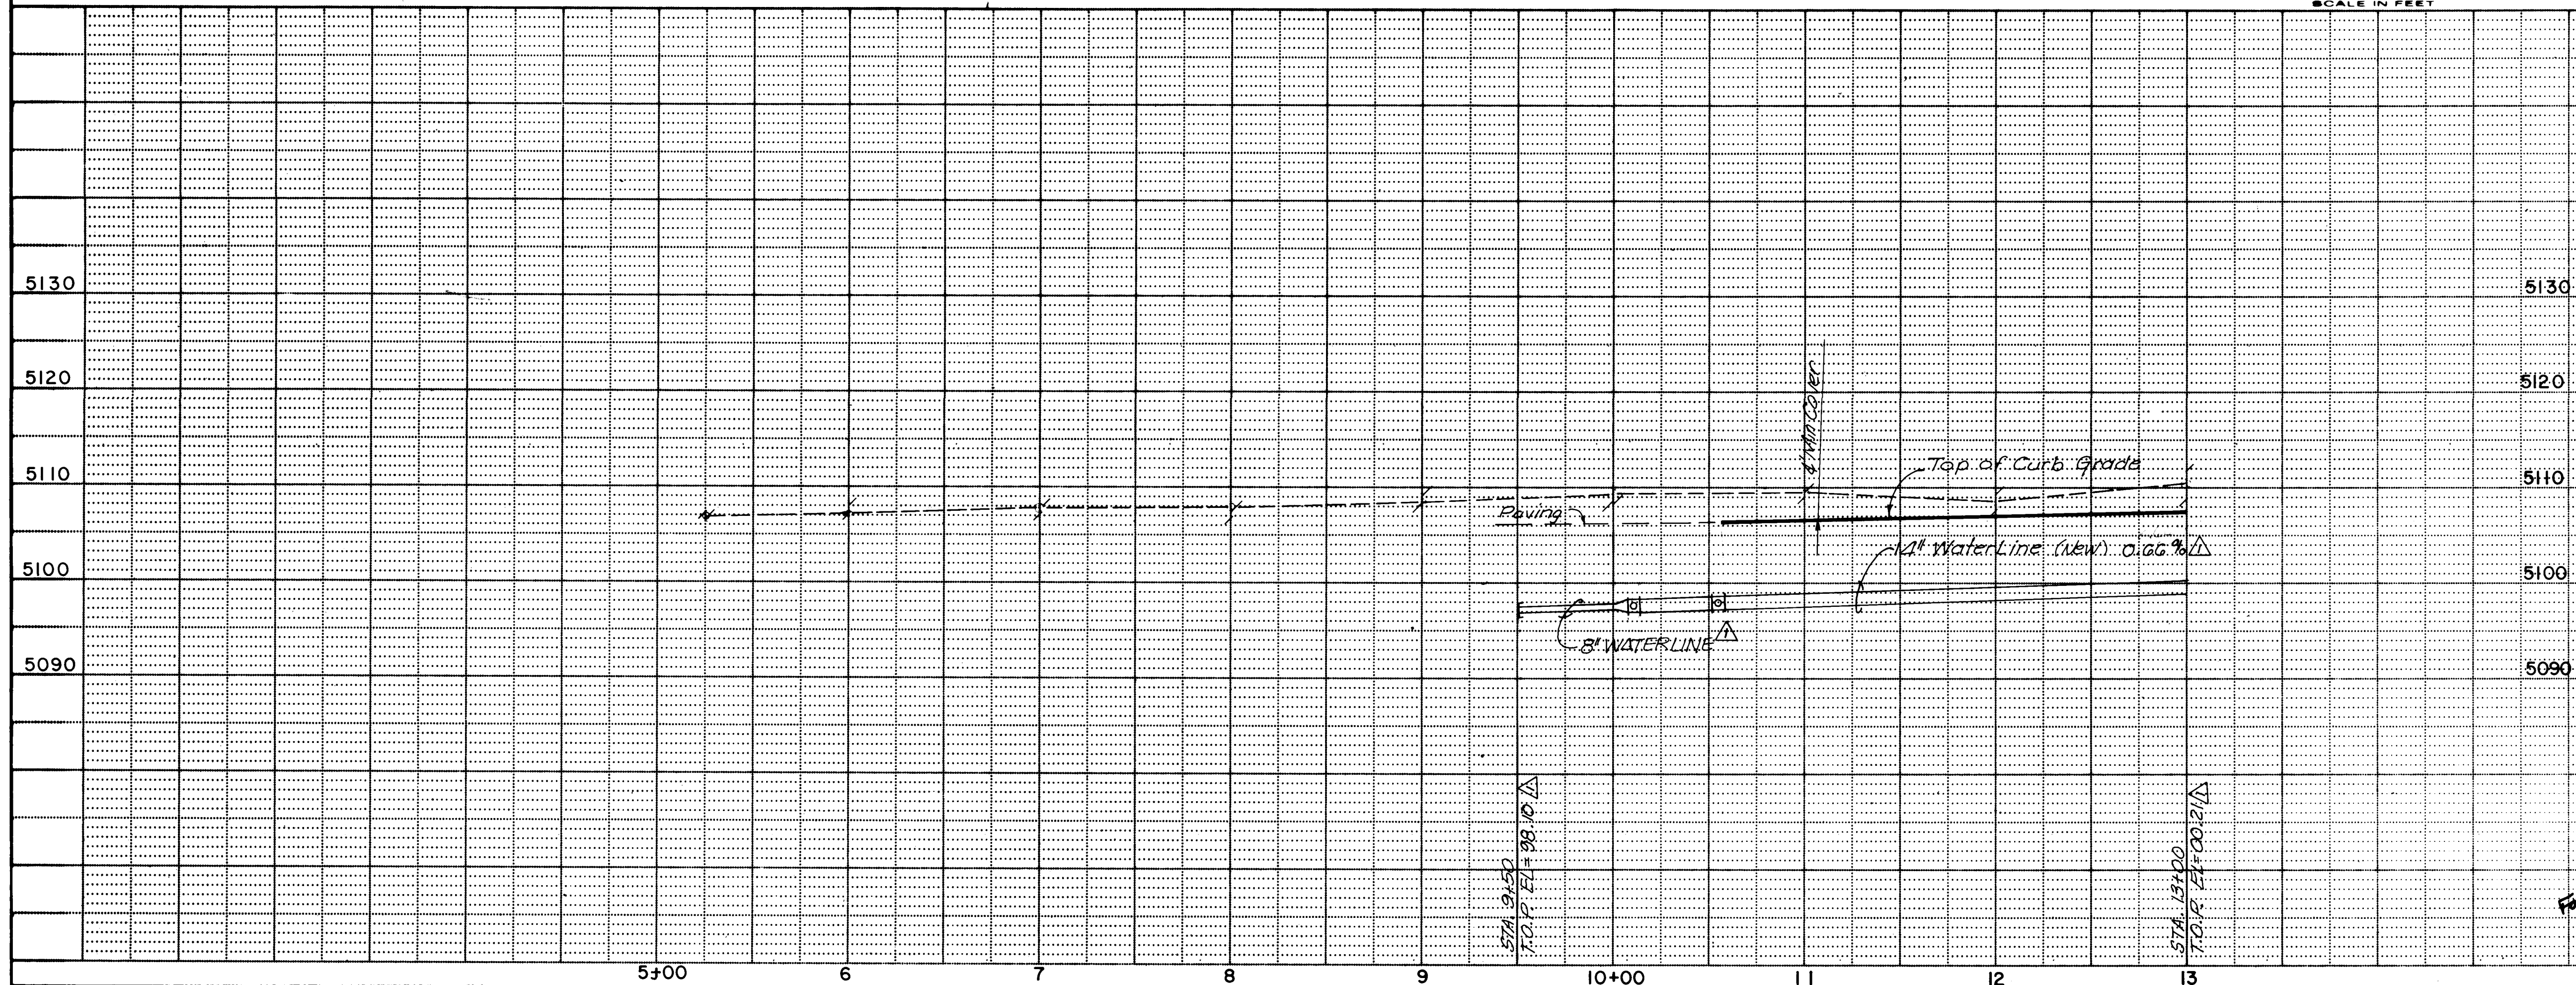


1 2 3 4 5 6 7 8 9 10 11 12
2 4 3 2 2 9 3 9 9 0

WATER


CITY OF ALBUQUERQUE PUBLIC WORKS DEPARTMENT SPECIAL ASSESSMENT DISTRICT NO. 218					
68 th STREET					
APPROVALS	ENGINEER	DATE	APPROVALS	ENGINEER	DATE
City Engineer	Rogelio P. Hernandez	3-14-89	Liquid Waste	Rogelio P. Hernandez	3/16/89
A.C.E. Design	"	"	Traffic	Rogelio P. Hernandez	3/16/89
A.C.E. Hydrology	CAM	NA	Water	Rogelio P. Hernandez	3/16/89
DRAWING NO. 3229		MAP NO. H-10 & J-10		SHEET 39 OF 52	

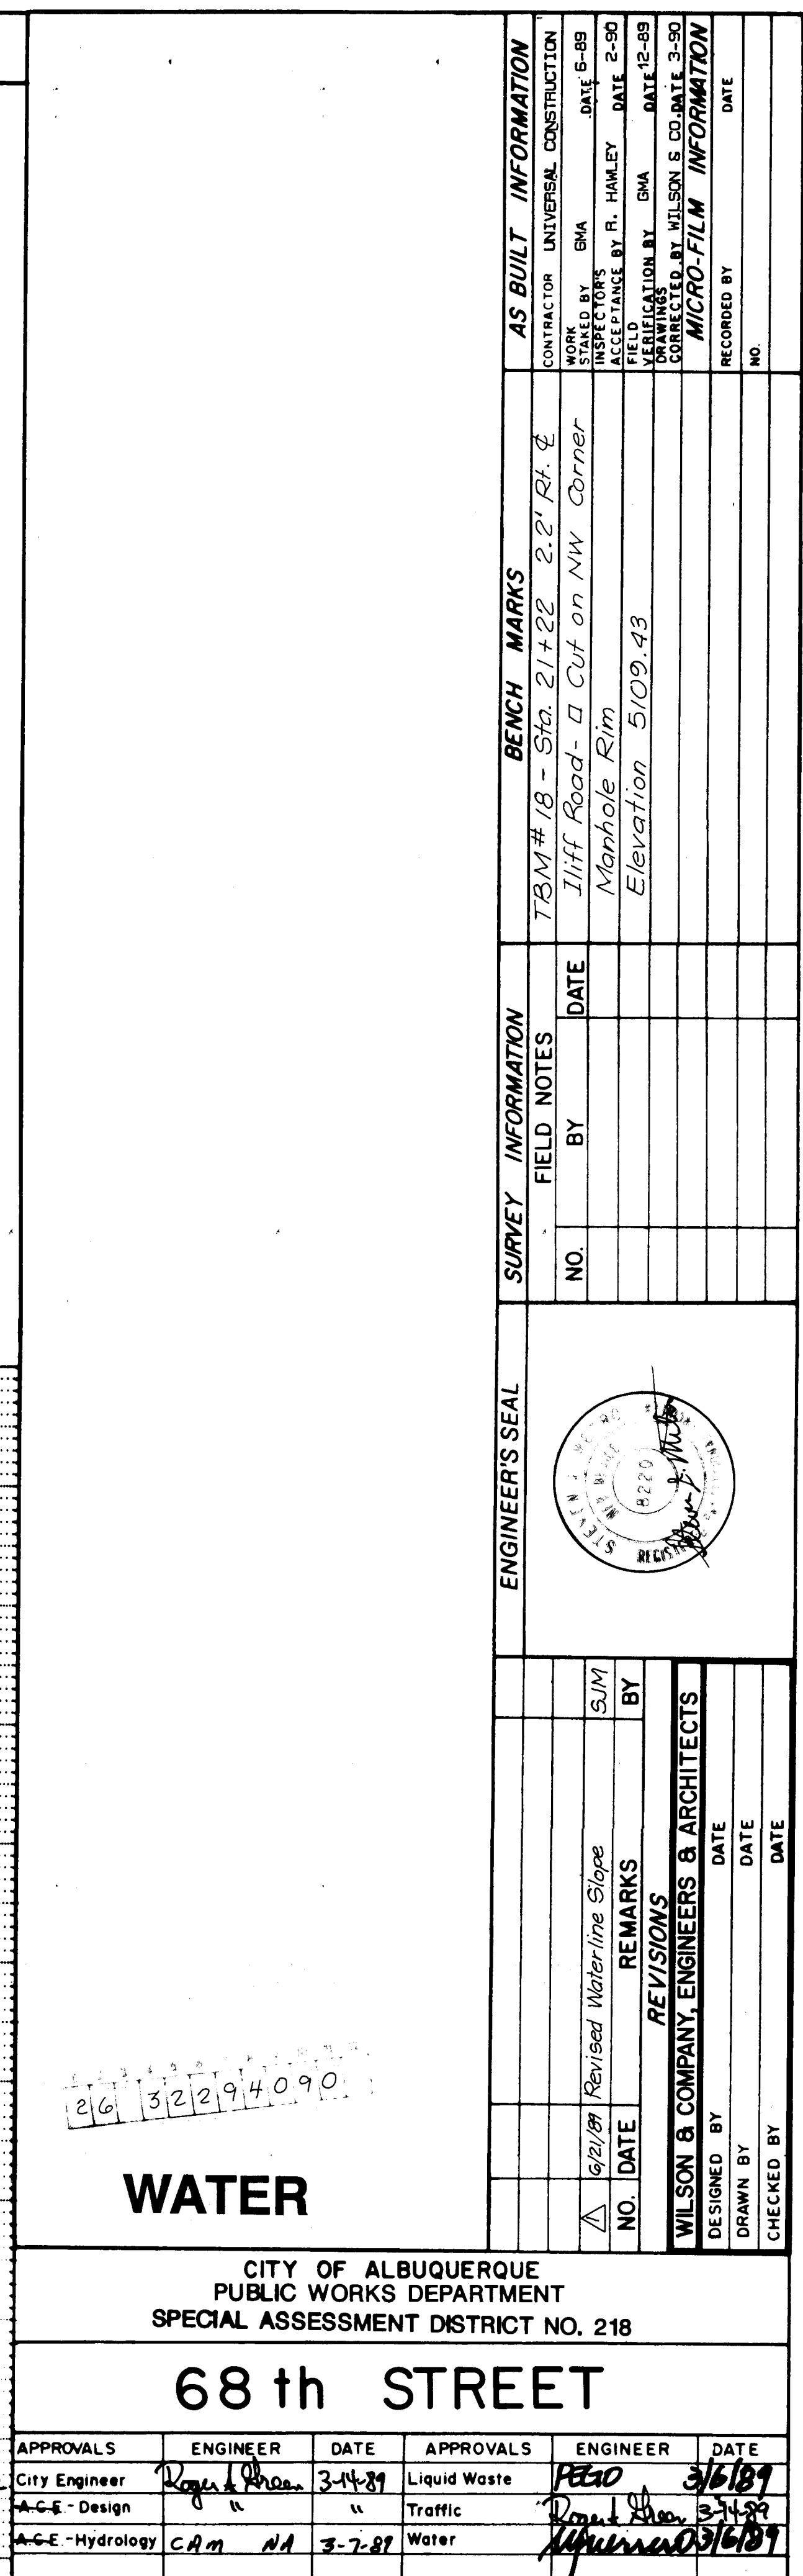

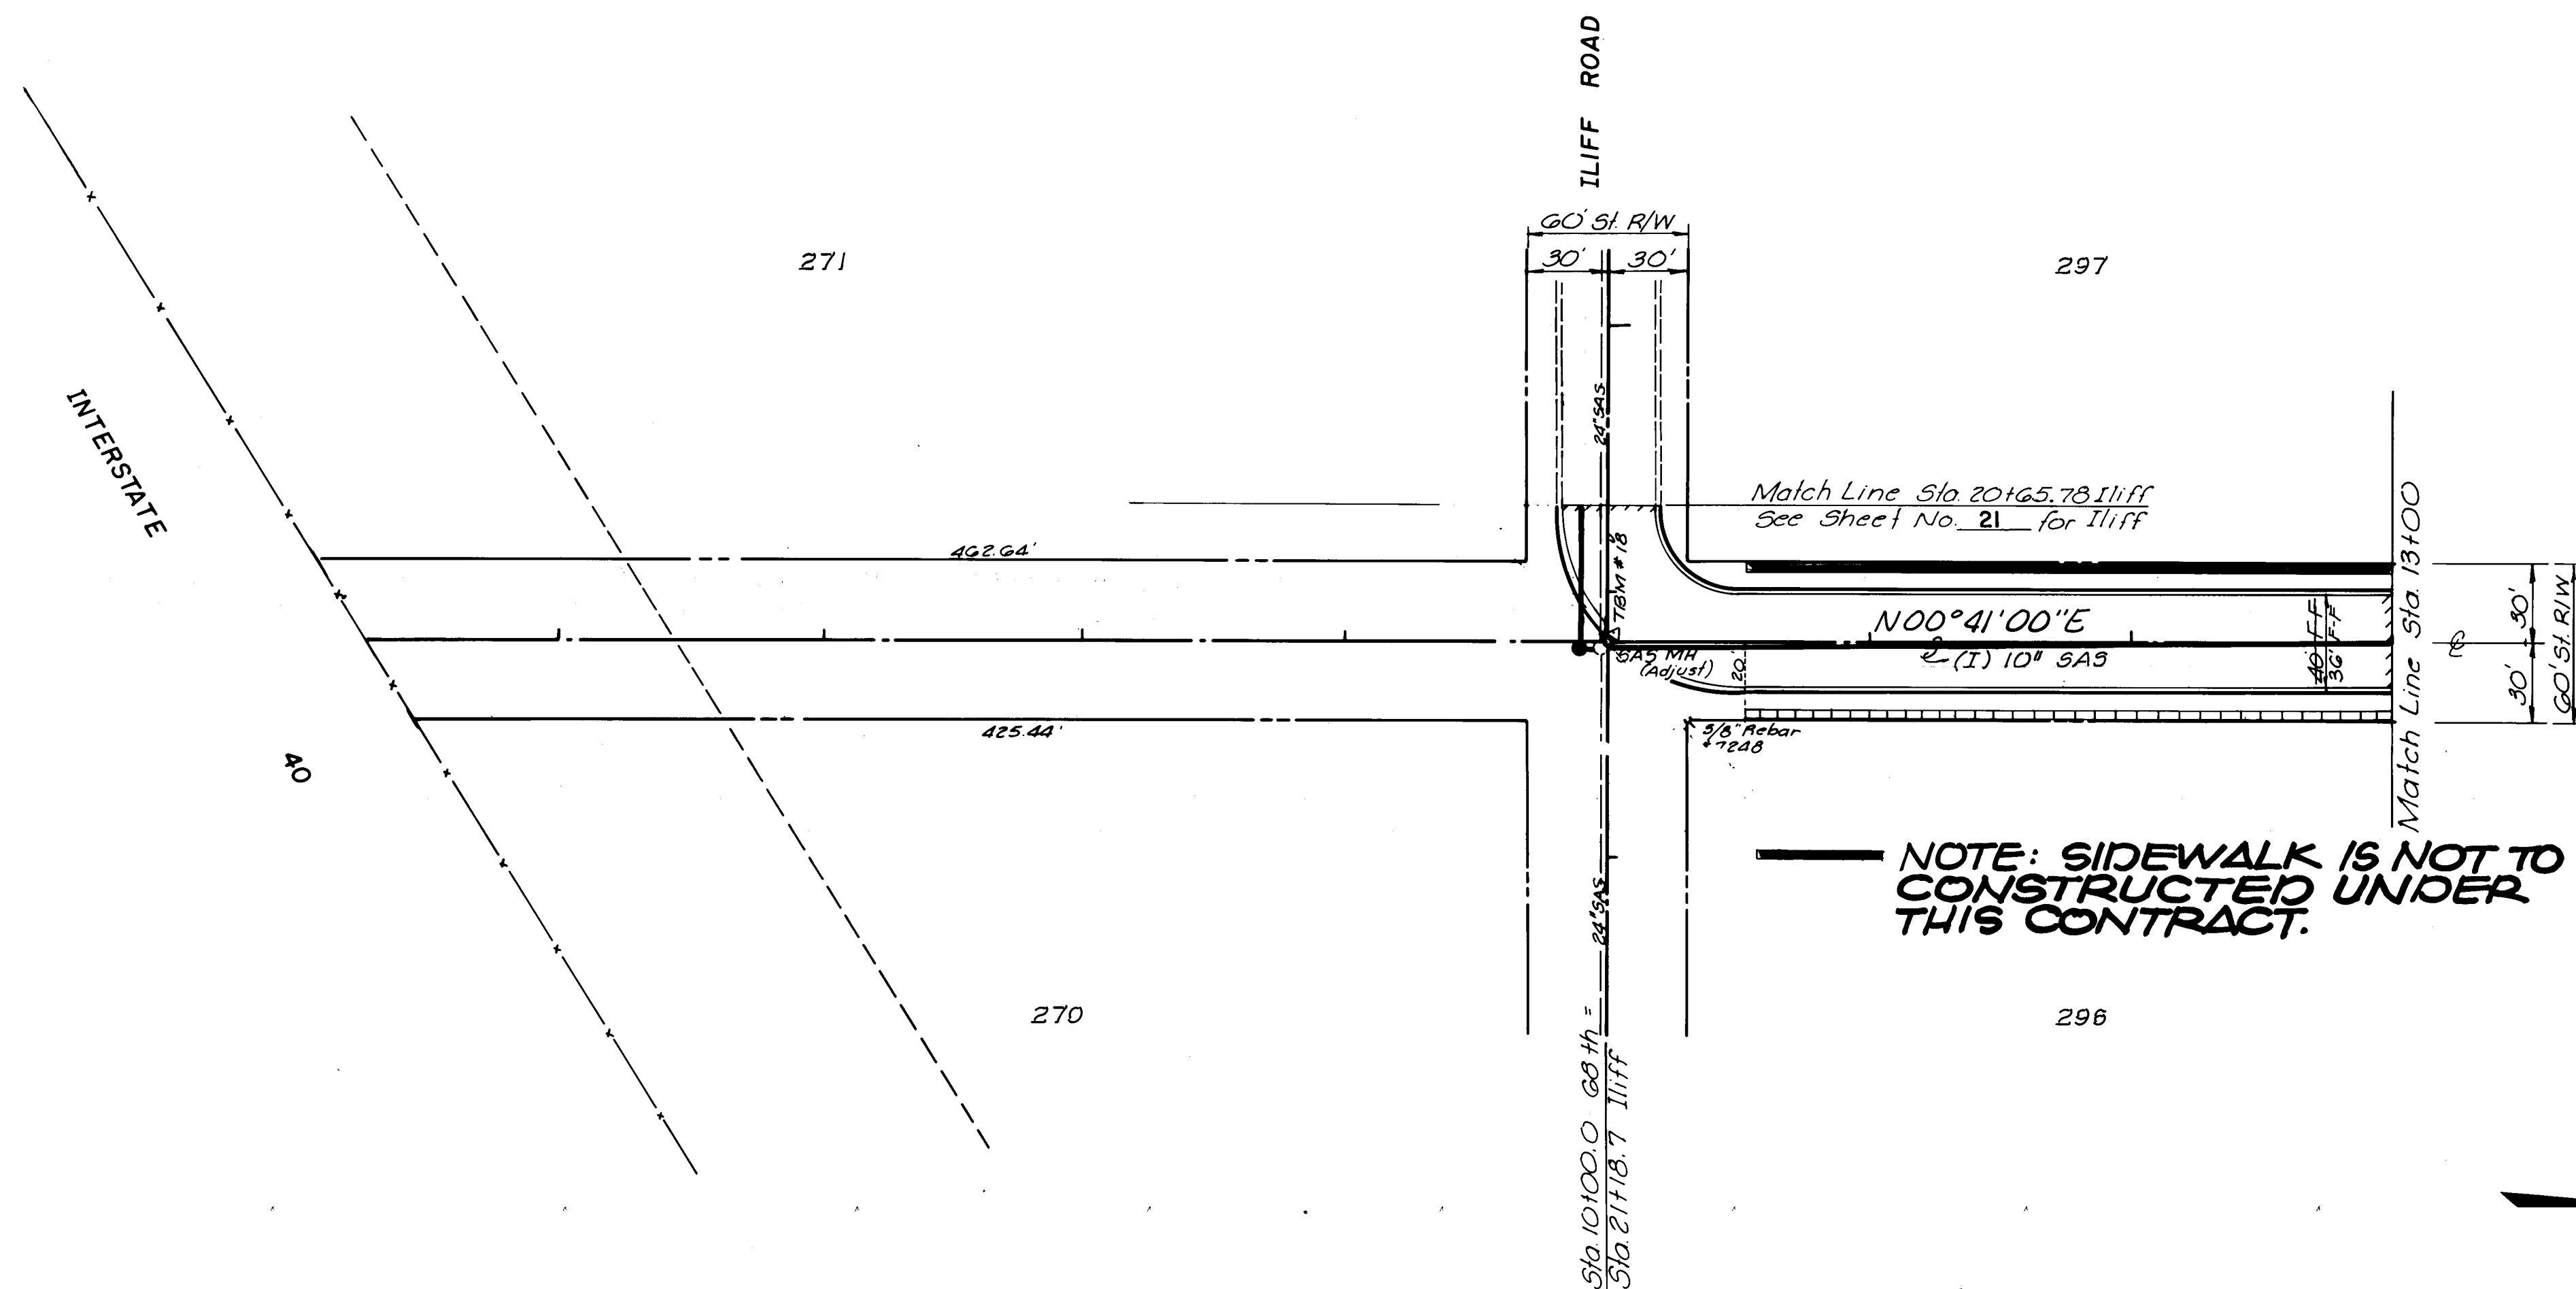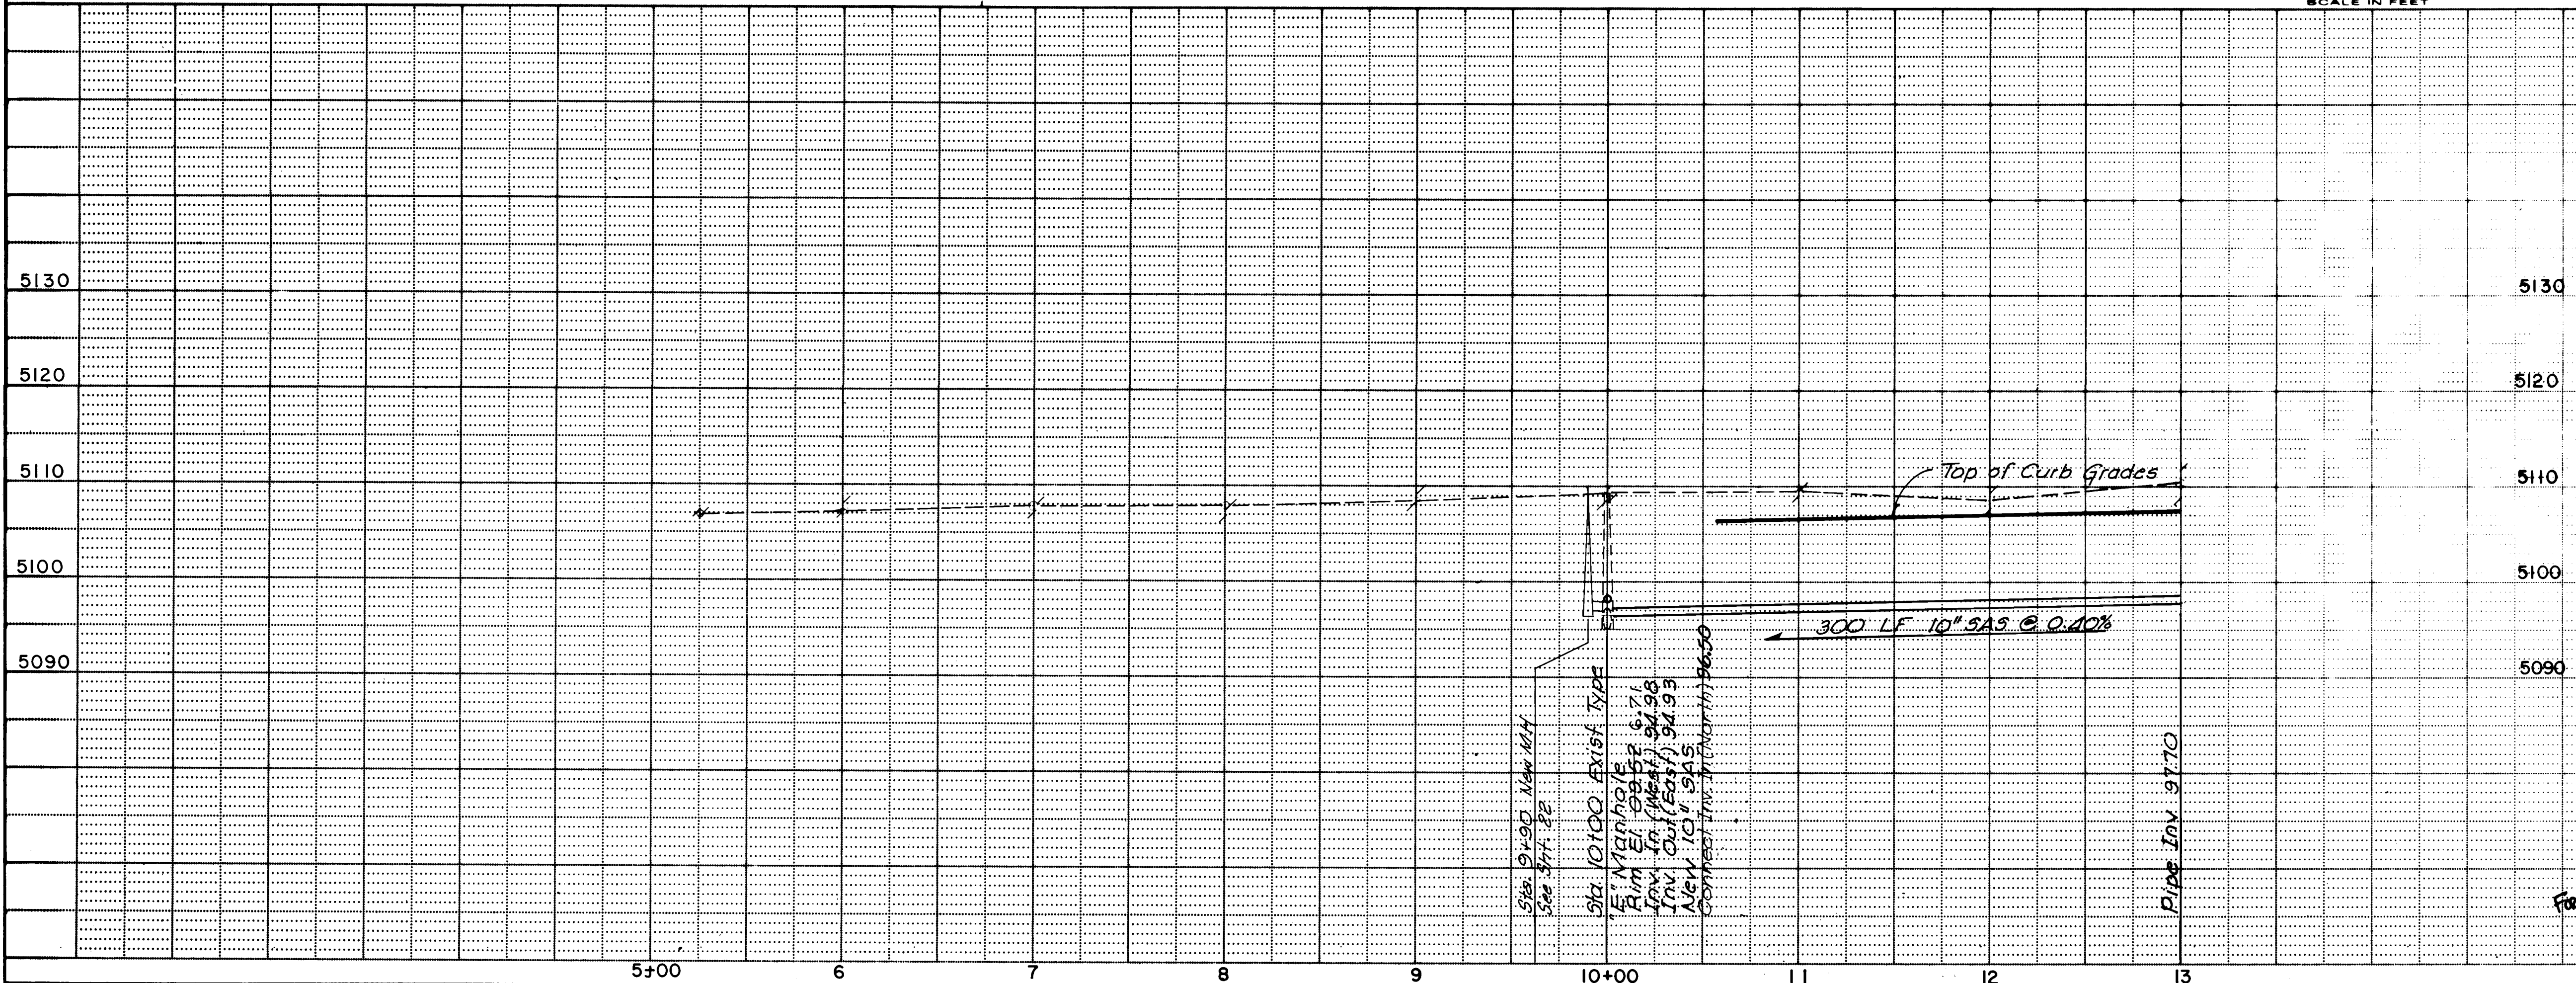


**- NOTE: SIDEWALK IS NOT TO BE
CONSTRUCTED UNDER
THIS CONTRACT.**

TOWN OF ATRISCO GRANT - UNIT NO. EIGHT

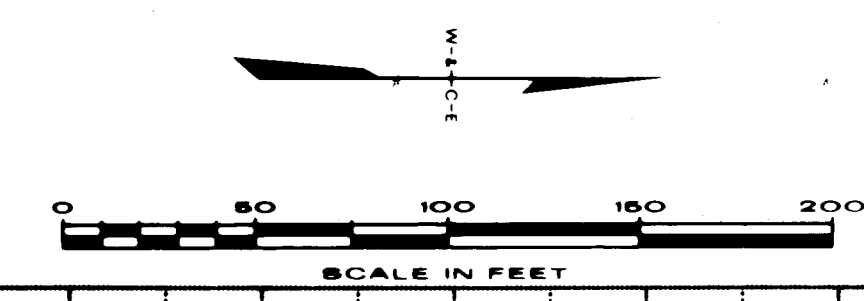

SURVEY INFORMATION		BENCH MARKS		AS BUILT INFORMATION	
NO.	FIELD NOTES	DATE	BY	CONTRACTOR UNIVERSAL CONSTRUCTION	
				WORK STARTED BY	DATE
				BY GMA	DATE 6-89
				ACCEPTED BY R. HAMLEY	DATE 2-90
				FIELD VERIFICATION BY GMA	DATE 12-89
				CORRECTED BY WILSON S CO.	DATE 3-90
				MICRO-FILM INFORMATION	
				RECORDED BY	DATE
				NO.	

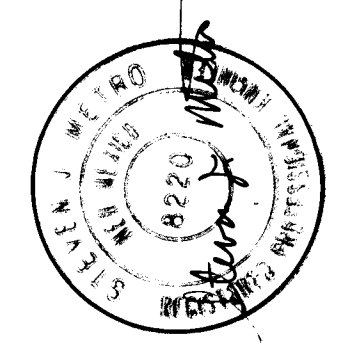[illegible]

SAN. SEWER

CITY OF ALBUQUERQUE
PUBLIC WORKS DEPARTMENT
SPECIAL ASSESSMENT DISTRICT NO. 218

68 th STREET

APPROVALS	ENGINEER	DATE	APPROVALS	ENGINEER	DATE
City Engineer	Rogayeh Shera	3-14-89	Liquid Waste	Murphy	3/16/89
AEE: Design	"	"	Traffic	Rogayeh Shera	3/14/89
AEE: Hydrology	CAM NA	3-7-89	Water	1500	3/16/89

DRAWING NO.	3229	MAP NO. H-10 & J-10	SHEET 41 OF 52
-------------	-------------	------------------------	------------------------------



ILIFF ROAD

Sta. 10+56.5 20' Lt. E
(C) Double "C" Inlet
TC Elev = 06.34 25
Inv. Out = ~~00.80~~ 00.66
#24" (North) ~~01.00~~
(I) 1-30" x 28' (East) Cl. III RCP

See Sh. No. 22
for Storm
Drain Details.

Sta. 10+56.5 10' Rt. E
(c) 6' dia. Type "E" Manhole
Inv 30" (West) 00.30
Inv 36" (South) 99.26
Inv 30" (East) 00.20
Rim El - 95-87 G.05
I) 1' 36" x 36.5" (South)
P.C. III

S/O. 10+81.25-20 Lt. E
(c) Type "A" Inlet
TC Elev ~~66.47~~ 6.39
Inv. Out ~~0+50~~ 1.81
(I) 1-24" x 20' (South) C.I. III
RCP

Sta. 9+80 - 10' Rt. E
(c) 6' dia. Type "E" Manhole
Inv 30" (West) 98.97 99.02
Inv 48" (North) 98.22 99.02
Inv 48" (South) 98.22 98.14
Rim E 97.00 6.75
(I) 1-48" x 320' RCP (South) CI III

Sta. 6+20.40 R+E
End of Pipe
R 97.50
97.99

Sta. 10+20 - 10' Rt. E
(c) 6' dia. Type "E" Manhole
Inv 30" (West) ~~99.03~~ 99.35
Inv 36" (North) ~~99.03~~ 98.18
Inv 48" (South) ~~98.28~~ 98.17
Rim El ~~98.84~~ 6.07
(I) 1-48" x 40' (South) R.C.C. III

Sta. 10+56.5-20' Rt. E
(C) Double "C" Inlet
TC Elev = 06.34 32
Inv. Out = ~~00.00~~ 00.83
Inv 24" (North) ~~0+00~~
(I) 1-30" x 8' (West) Cl. III RCP

Sta. 10+81.25 - 20' Rt. E
(c) Type "A" Inlet
TC Elev ~~66.47~~ 6.38
Inv. Out ~~61.50~~ 1.78
(I) 1-24" x 20' (South) CI. III
RCP

NOTE: SIDEWALK IS NOT TO BE CONSTRUCTED UNDER THIS CONTRACT.

TOWN OF ATRISCO GRANT - UNIT NO. EIGHT



A line graph titled "Retention Pond Water Level Chart" showing water level in feet over time. The y-axis is labeled "Water Level (ft)" and ranges from 0 to 10. The x-axis is labeled "Time (hr)" and ranges from 0 to 10. The graph shows a series of peaks and troughs. Key points are labeled: (0, 10), (2, 5), (4, 2), (6, 5), (8, 10), (10, 5). A horizontal line is drawn at 5 feet, labeled "Avg. 5.0". A vertical line is drawn at 5 hours, labeled "Avg. 5.0". A diagonal line is drawn from (0, 10) to (10, 0), labeled "Avg. 5.0".

26 32294390

STORM DRAIN

CITY OF ALBUQUERQUE
PUBLIC WORKS DEPARTMENT
SPECIAL ASSESSMENT DISTRICT NO. 218

68 th STREET

APPROVALS	ENGINEER	DATE	APPROVALS	ENGINEER	DATE
City Engineer	<i>Rogel P. Sison</i>	3-14-89	Liquid Waste	<i>REGO</i>	3/6/89
ACE - Design	"	"	Traffic	<i>Dizon & Sison</i>	3-14-89
ACE - Hydrology	<i>CAM</i>	3-7-89	Water	<i>REGO</i>	3/6/89



DRAWING NO.	3229	MAP NO. H-10 & J-10	SHEET 43 OF 52
----------------	-------------	------------------------	------------------------------

RECORD DRAWING
DATE 3-1-90

GARDNER, MASON & ASSOCIATES, INC.
ENGINEERS & PLANNERS
ALBUQUERQUE, N.M.

WILSON & COMPANY
ENGINEERS & ARCHITECTS
ALBUQUERQUE NEW MEXICO



87-514

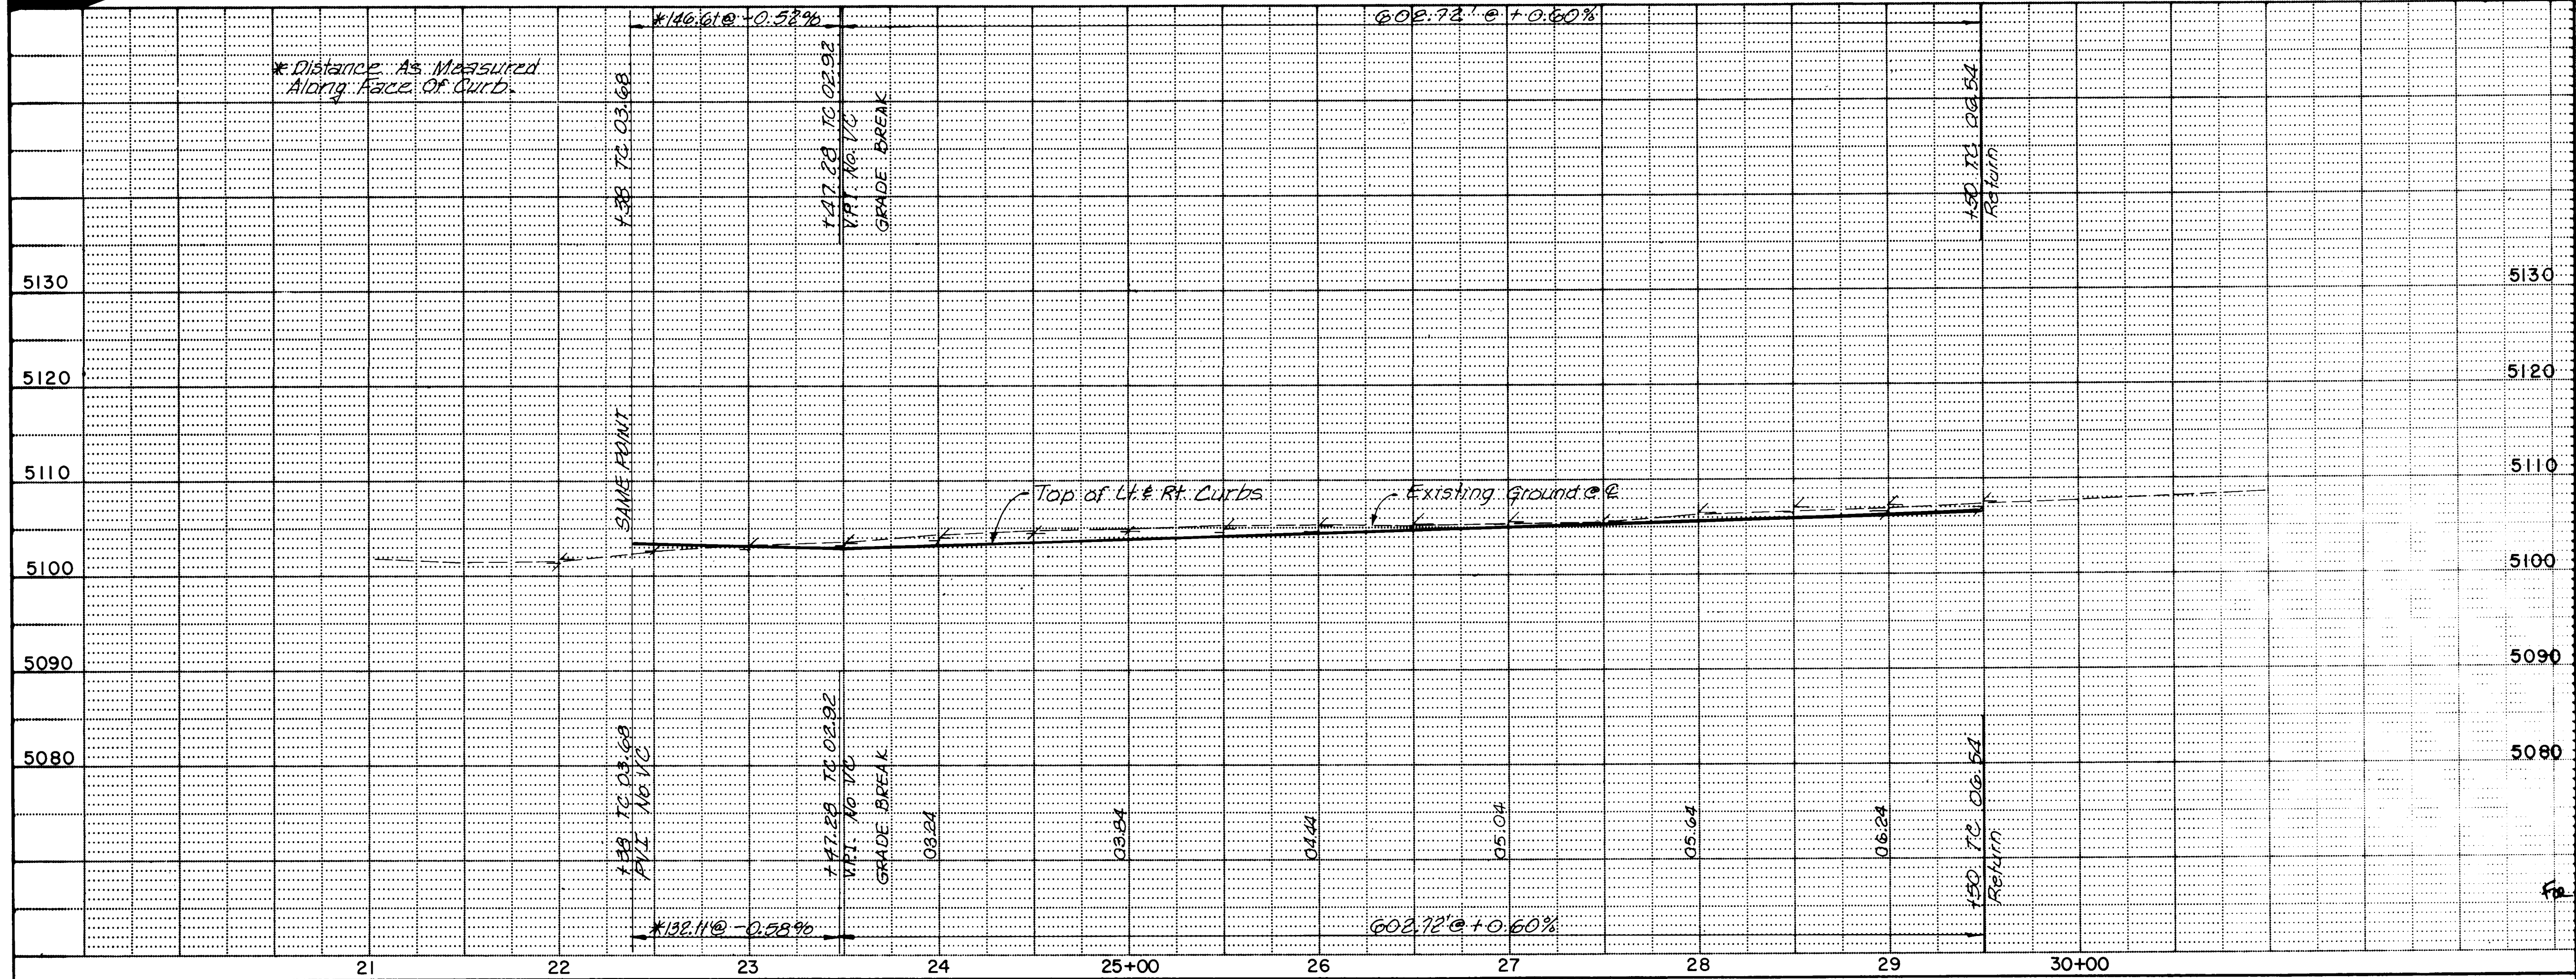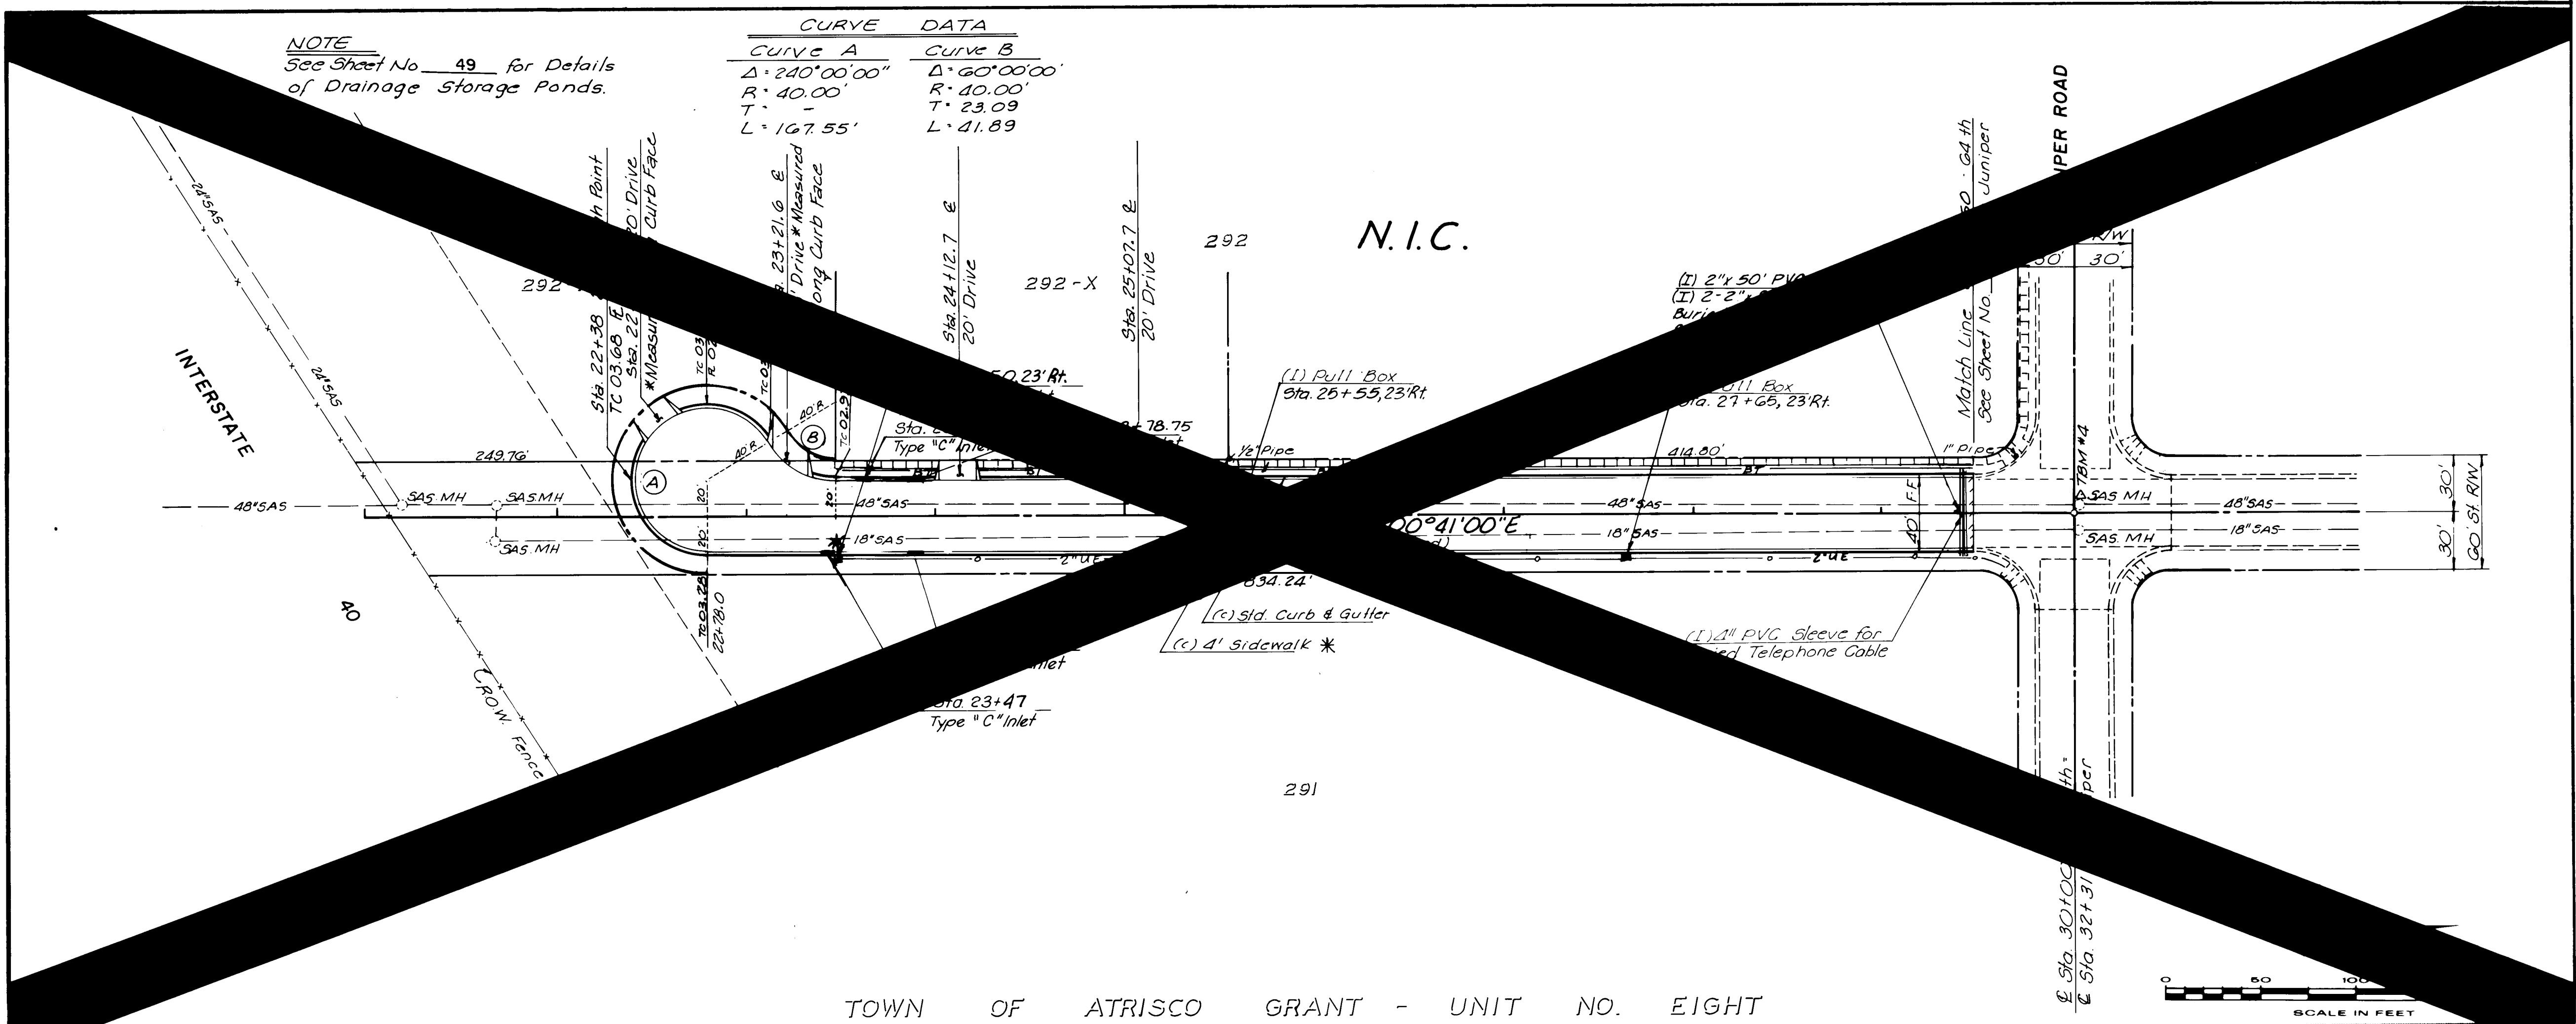

PAVING

CITY OF ALBUQUERQUE PUBLIC WORKS DEPARTMENT SPECIAL ASSESSMENT DISTRICT NO. 218			
64th STREET			
APPROVALS	ENGINEER	DATE	APPROVALS
City Engineer	Rogers	3-14-87	Liquid Waste
AG-Design	"	"	Traffic
AG-Hydrology	CAM	3-7-87	Water
DRAWING NO. 3229		SHEET 44 OF 52	

ENGINEER'S SEAL		SURVEY INFORMATION		BENCH MARKS		AS BUILT INFORMATION	
		NO.	BY	DATE	TBM #4 - Sta. 32+20 - 3' Lt. E	CONTRACTOR	UNIVERSAL CONSTRUCTION
		REVISIONS		DATE	Cluniper Road - Cut on Manhole	WORK	DATE
NO.		DATE	REMARKS	BY	DATE	DATE	DATE
DESIGNED BY		DATE	WILSON & COMPANY, ENGINEERS & ARCHITECTS		DATE	DATE	DATE
DRAWN BY		DATE	RECORDED BY		DATE	DATE	DATE
CHECKED BY		DATE	MICRO-FILM INFORMATION		DATE	DATE	DATE

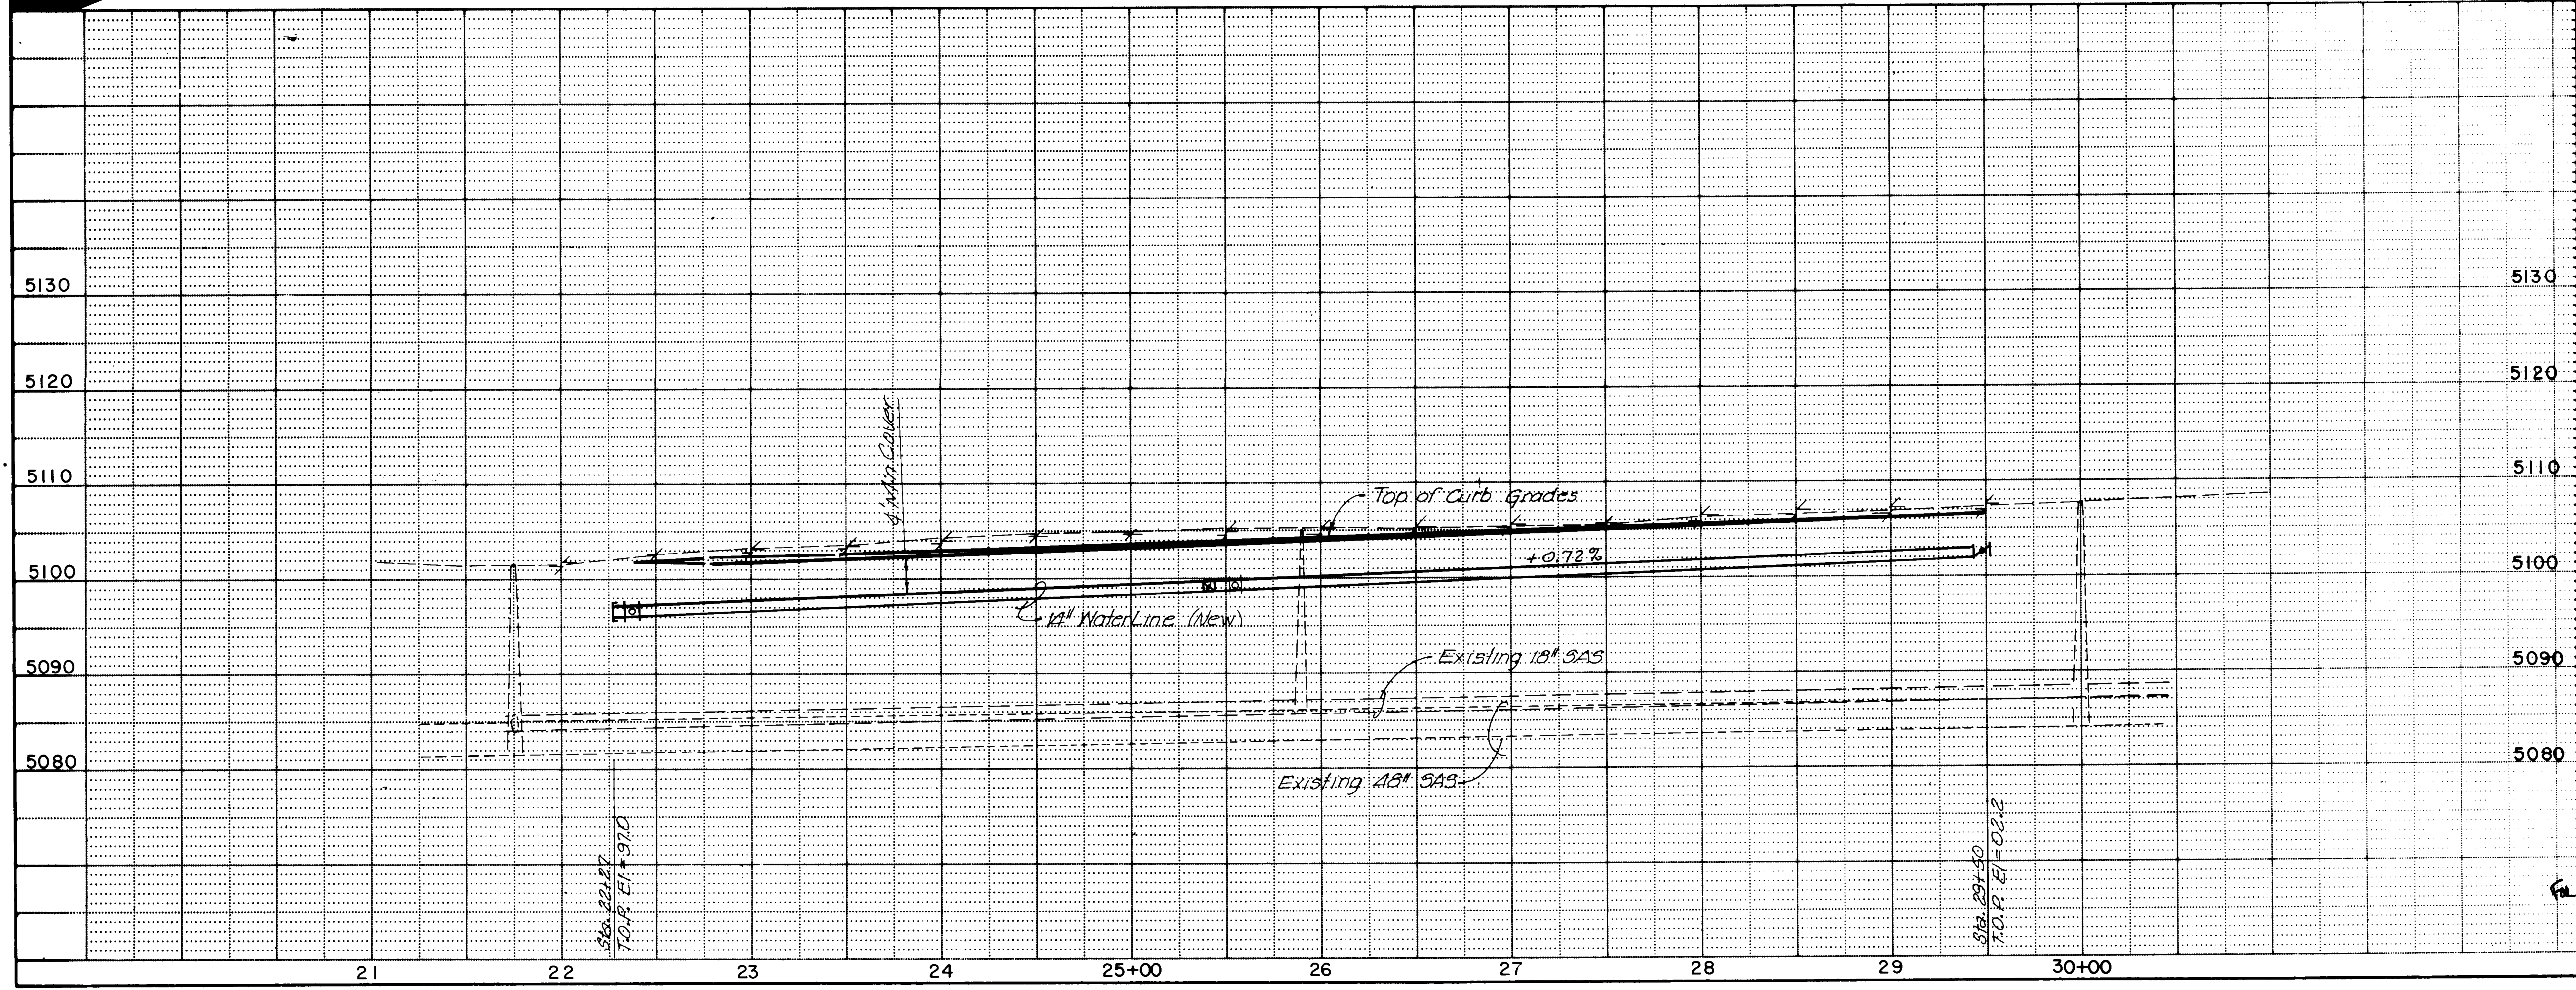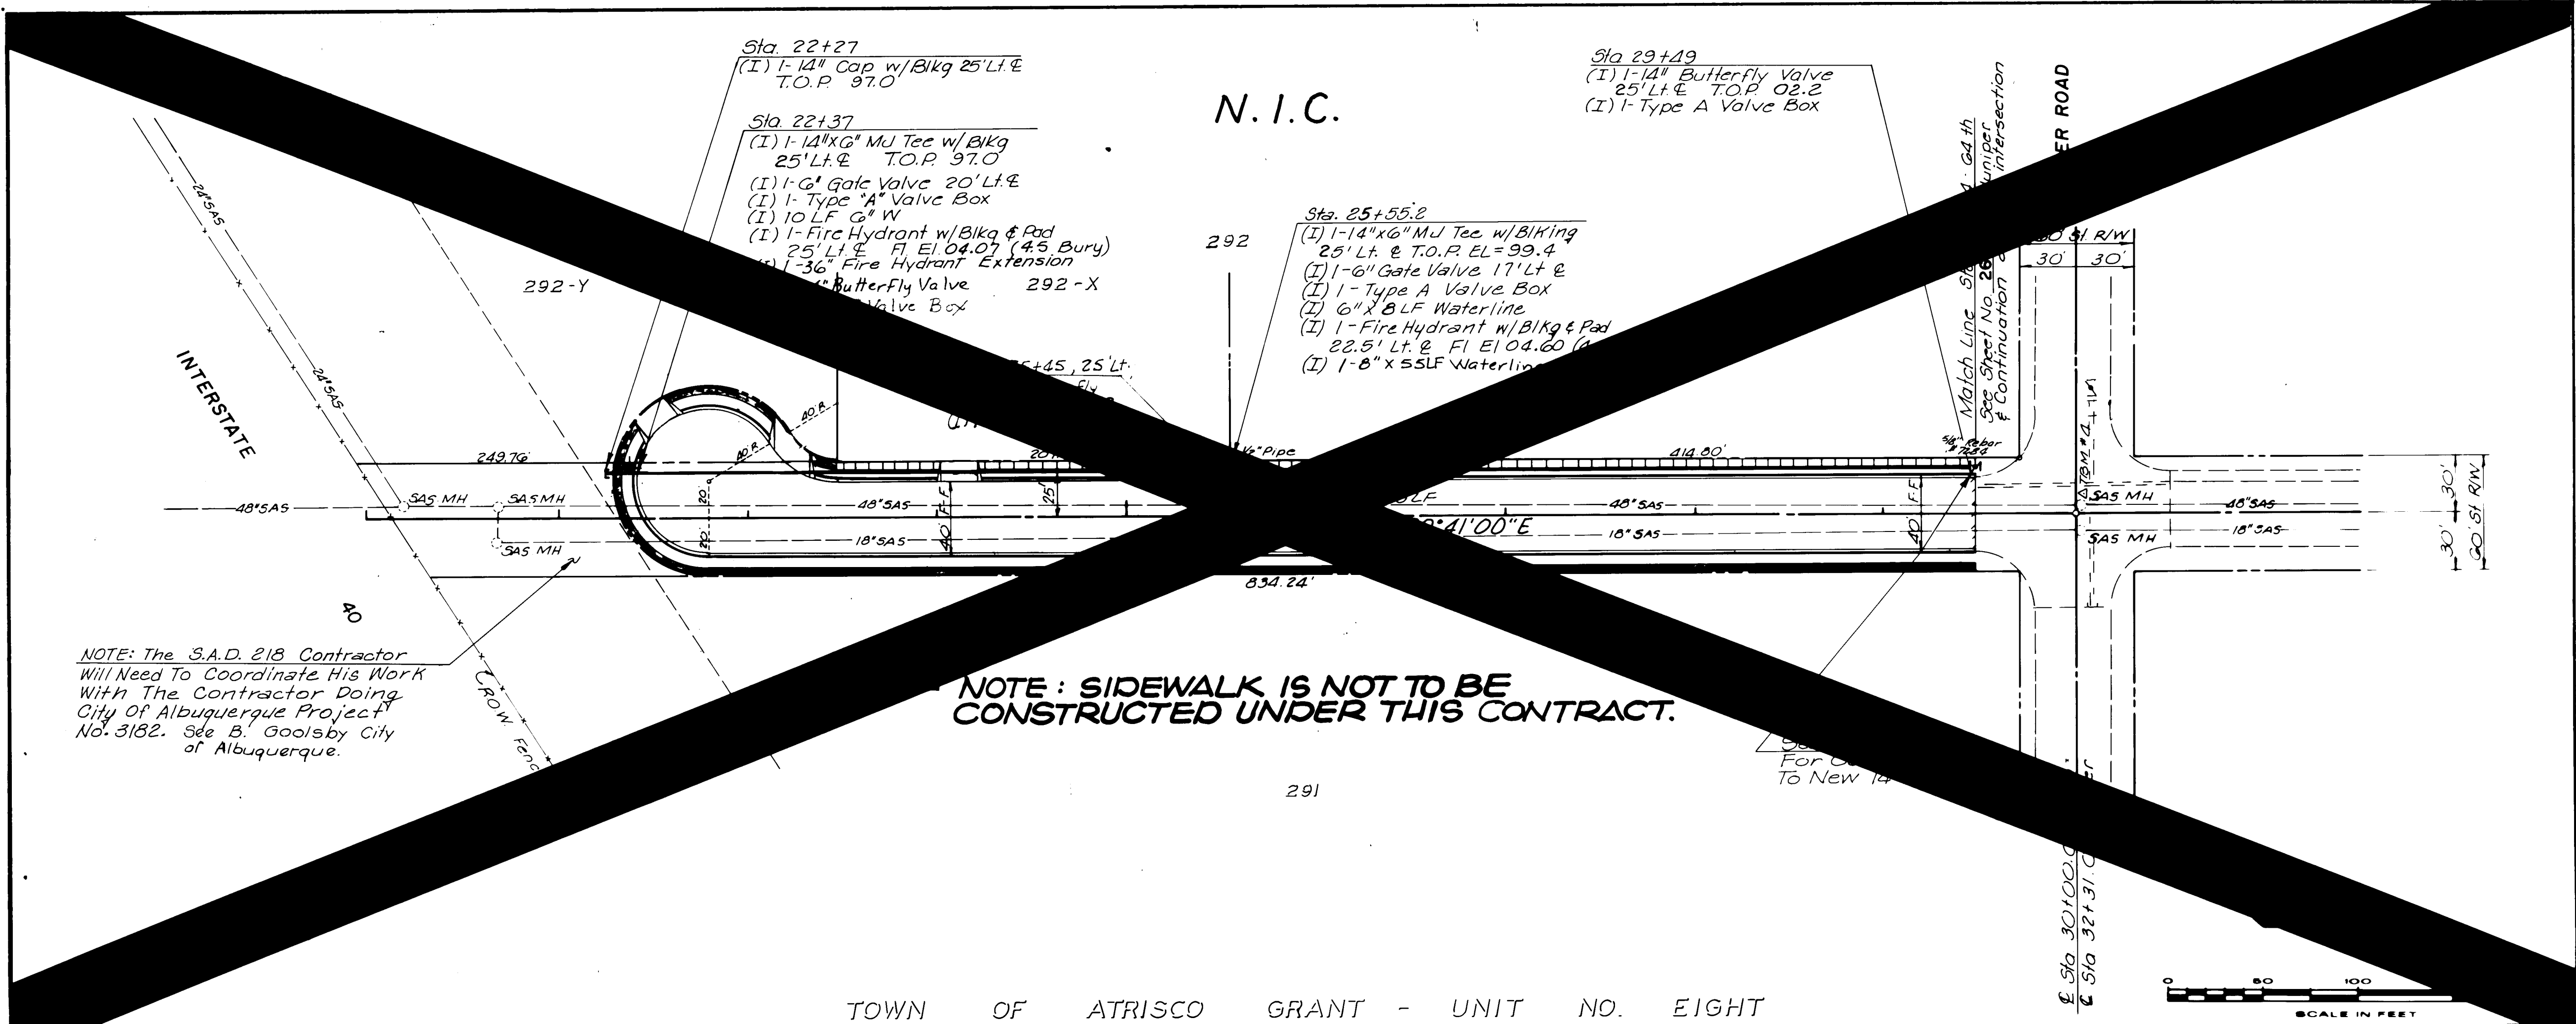

ENGINEER'S SEAL			SURVEY INFORMATION			BENCH MARKS			AS BUILT INFORMATION		
REVISIONS			FIELD NOTES			TBM #4 - Sta. 32+20.3' Lt & El			CONTRACTOR UNIVERSAL CONSTRUCTION		
NO.	DATE	REMARKS	NO.	BY	DATE	cluniper Road - + Cut on Manhole Rim Elevation 5108.91			WORK	INSPECTOR	DATE
WILSON & COMPANY, ENGINEERS & ARCHITECTS									STAKED BY	DATE	
DESIGNED BY									FIELD	DATE	
DRAWN BY									INSPECTED BY	DATE	
CHECKED BY									VERIFIED BY	DATE	
									CORRECTED BY	DATE	
									RECORDED BY	DATE	
									NO	DATE	

26 322294590

WATER

CITY OF ALBUQUERQUE
PUBLIC WORKS DEPARTMENT
SPECIAL ASSESSMENT DISTRICT NO. 218

64 th STREET

APPROVALS	ENGINEER	DATE	APPROVALS	ENGINEER	DATE
City Engineer	Ray & Shaw	3-14-89	Liquid Waste	Ray & Shaw	3/16/89
A-C-E - Design	"	"	Traffic	"	"
A-G-E - Hydrology	CAM	NA	Water	"	"



DRAWING NO. **3229** MAP NO. H-10 & J-10 SHEET **45** OF **52**

RECORD DRAWING
DATE 3-1-90

GARDNER, MASON & ASSOCIATES, INC.
ENGINEERS & PLANNERS
ALBUQUERQUE, N.M.

WILSON & COMPANY
ENGINEERS & ARCHITECTS
ALBUQUERQUE / NEW MEXICO

87-514

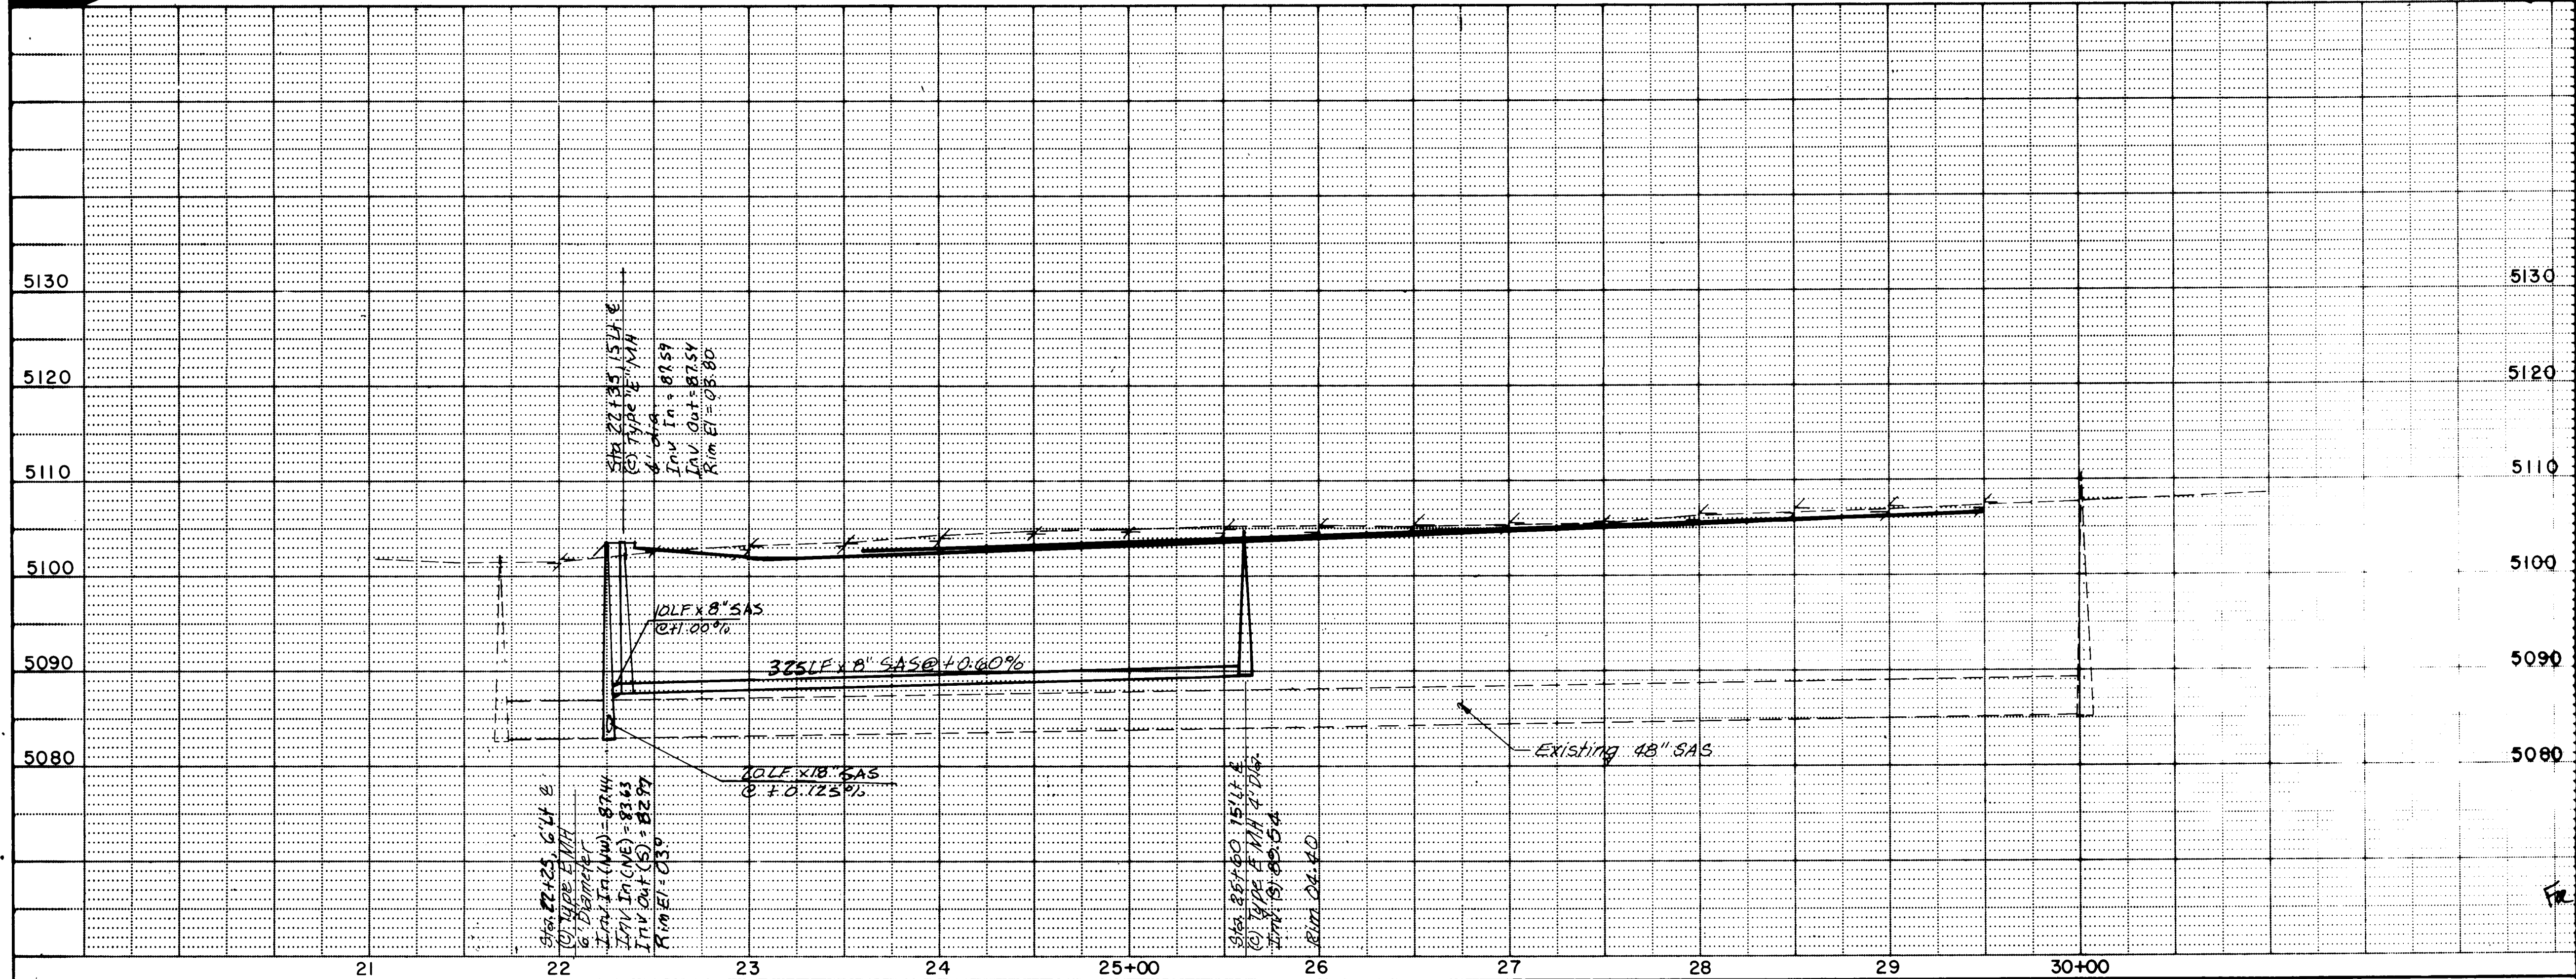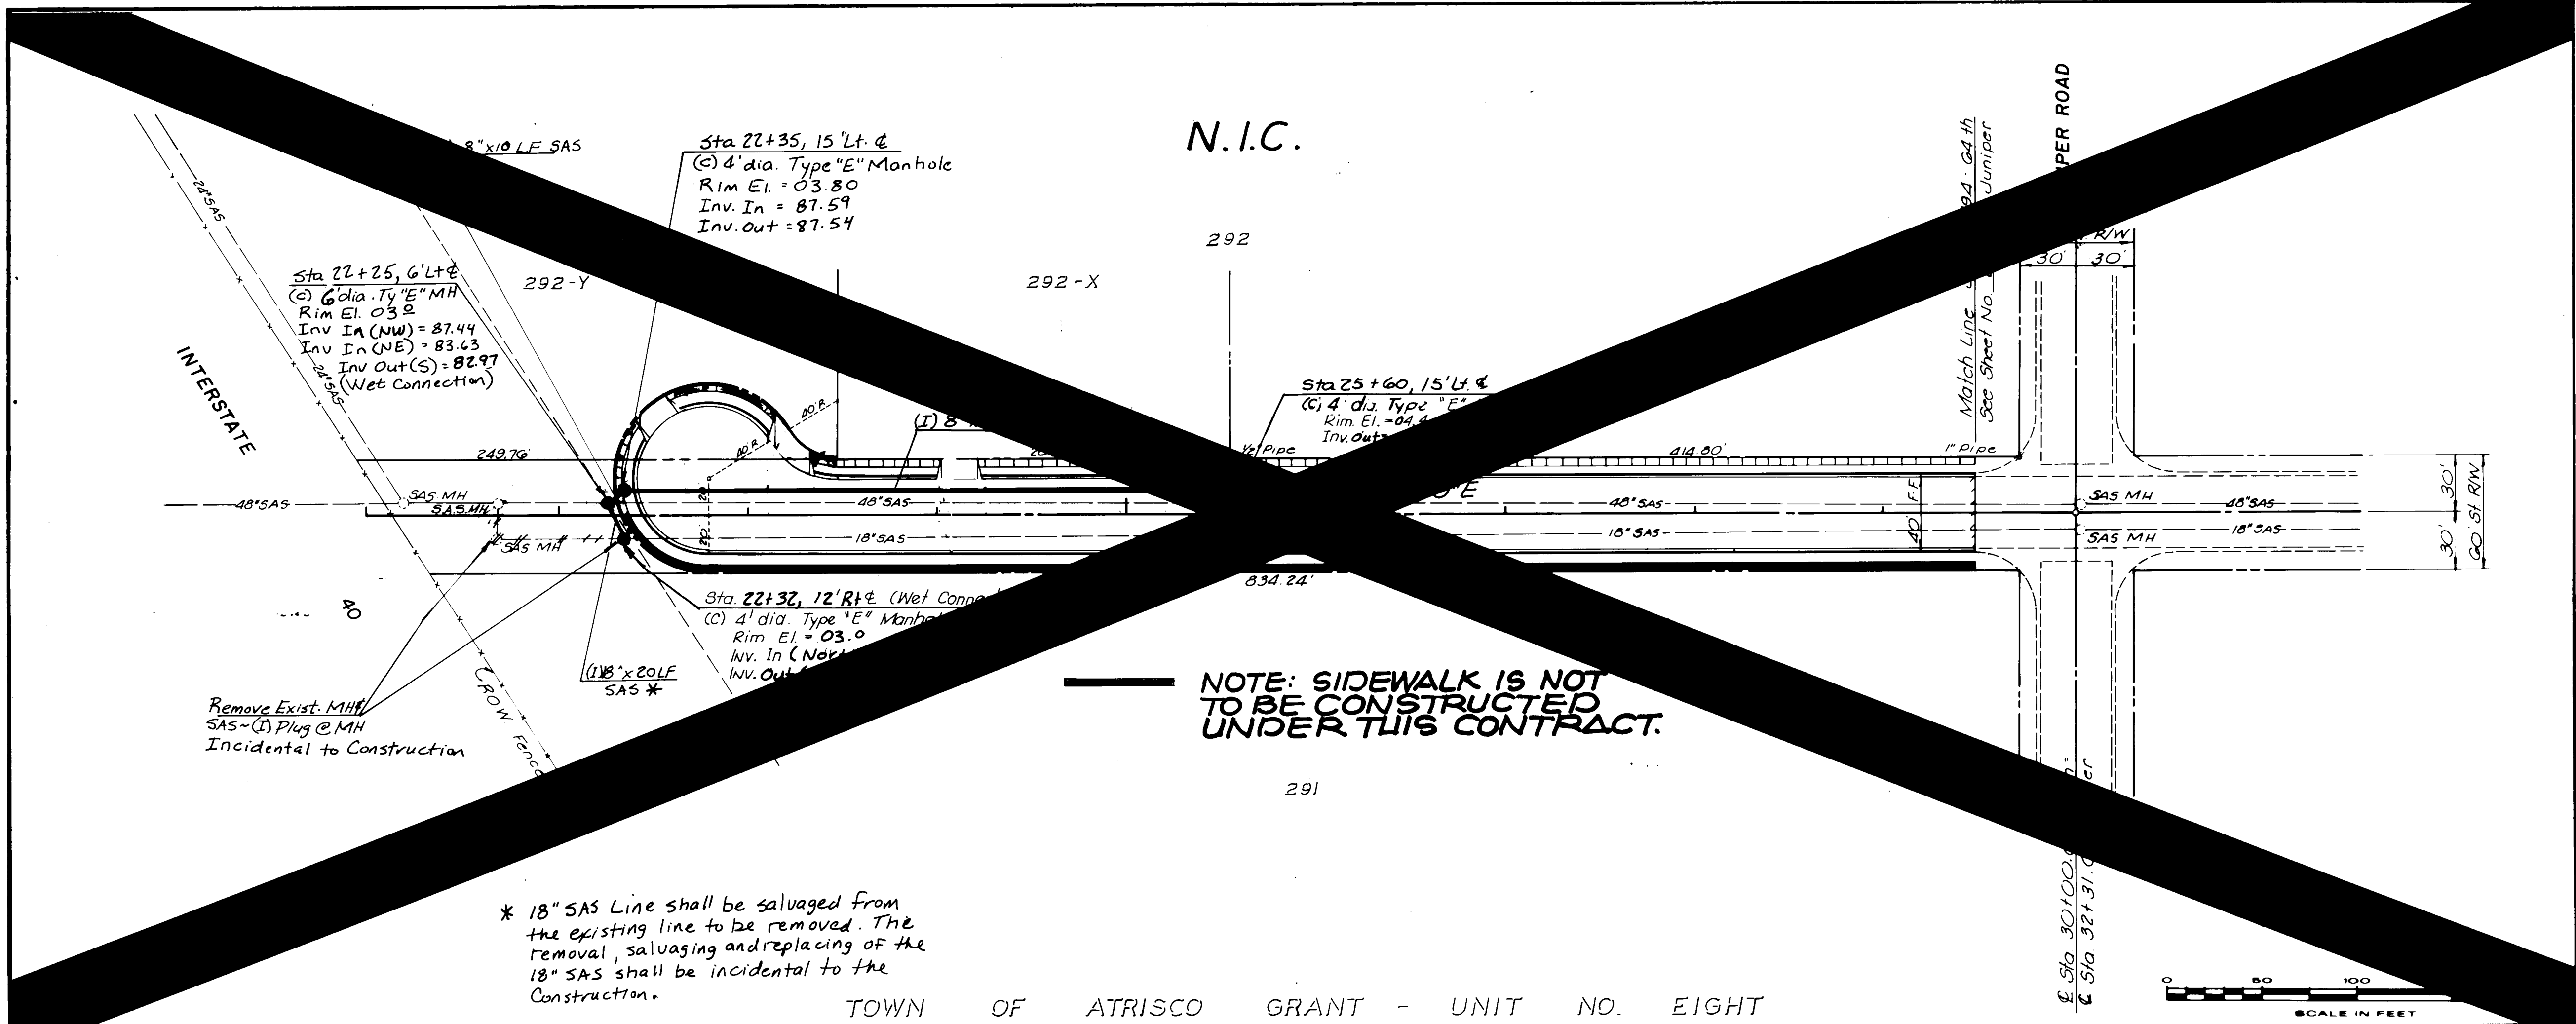

AS BUILT INFORMATION		BENCH MARKS		SURVEY INFORMATION		ENGINEER'S SEAL		REVISIONS		APPROVALS	
CONTRACTOR	UNIVERSAL CONSTRUCTION	TBM #4 - Sta 32+20	3' Lt. &	DATE	BY	NO.	DATE	REMARKS	BY	ENGINEER	DATE
WORK	DATE 8-89	Uniper Road - + Cut on Manhole								City Engineer	3-14-90
INSPECTOR'S	DATE 2-90	Rim Elevation 5108.91								ACE - Design	3-14-90
FIELD	DATE 2-90									ACE - Hydrology	3-14-90
VERIFICATION BY	DATE 2-90										
CORRECTED BY	DATE 3-90										
MICRO-FILM INFORMATION	DATE										
RECORDED BY	DATE										
NO.	DATE										

26 52294690

SAN. SEWER

CITY OF ALBUQUERQUE
PUBLIC WORKS DEPARTMENT
SPECIAL ASSESSMENT DISTRICT NO. 218

64 th STREET

APPROVALS	ENGINEER	DATE	APPROVALS	ENGINEER	DATE
City Engineer	Ray A. H.	3-14-90	Liquid Waste	Ray A. H.	3-14-90
ACE - Design	"	"	Traffic	Ray A. H.	3-14-90
ACE - Hydrology	CAM	3-7-89	Water	Ray A. H.	3-14-90



DRAWING NO. 3229 MAP NO. H-10 & J-10 SHEET 46 OF 52

RECORD DRAWING
DATE 3-1-90

GARDNER, MASON & ASSOCIATES, INC.
ENGINEERS & PLANNERS
ALBUQUERQUE, N.M.

WILSON & COMPANY
ENGINEERS & ARCHITECTS
ALBUQUERQUE, N.M.

87-514

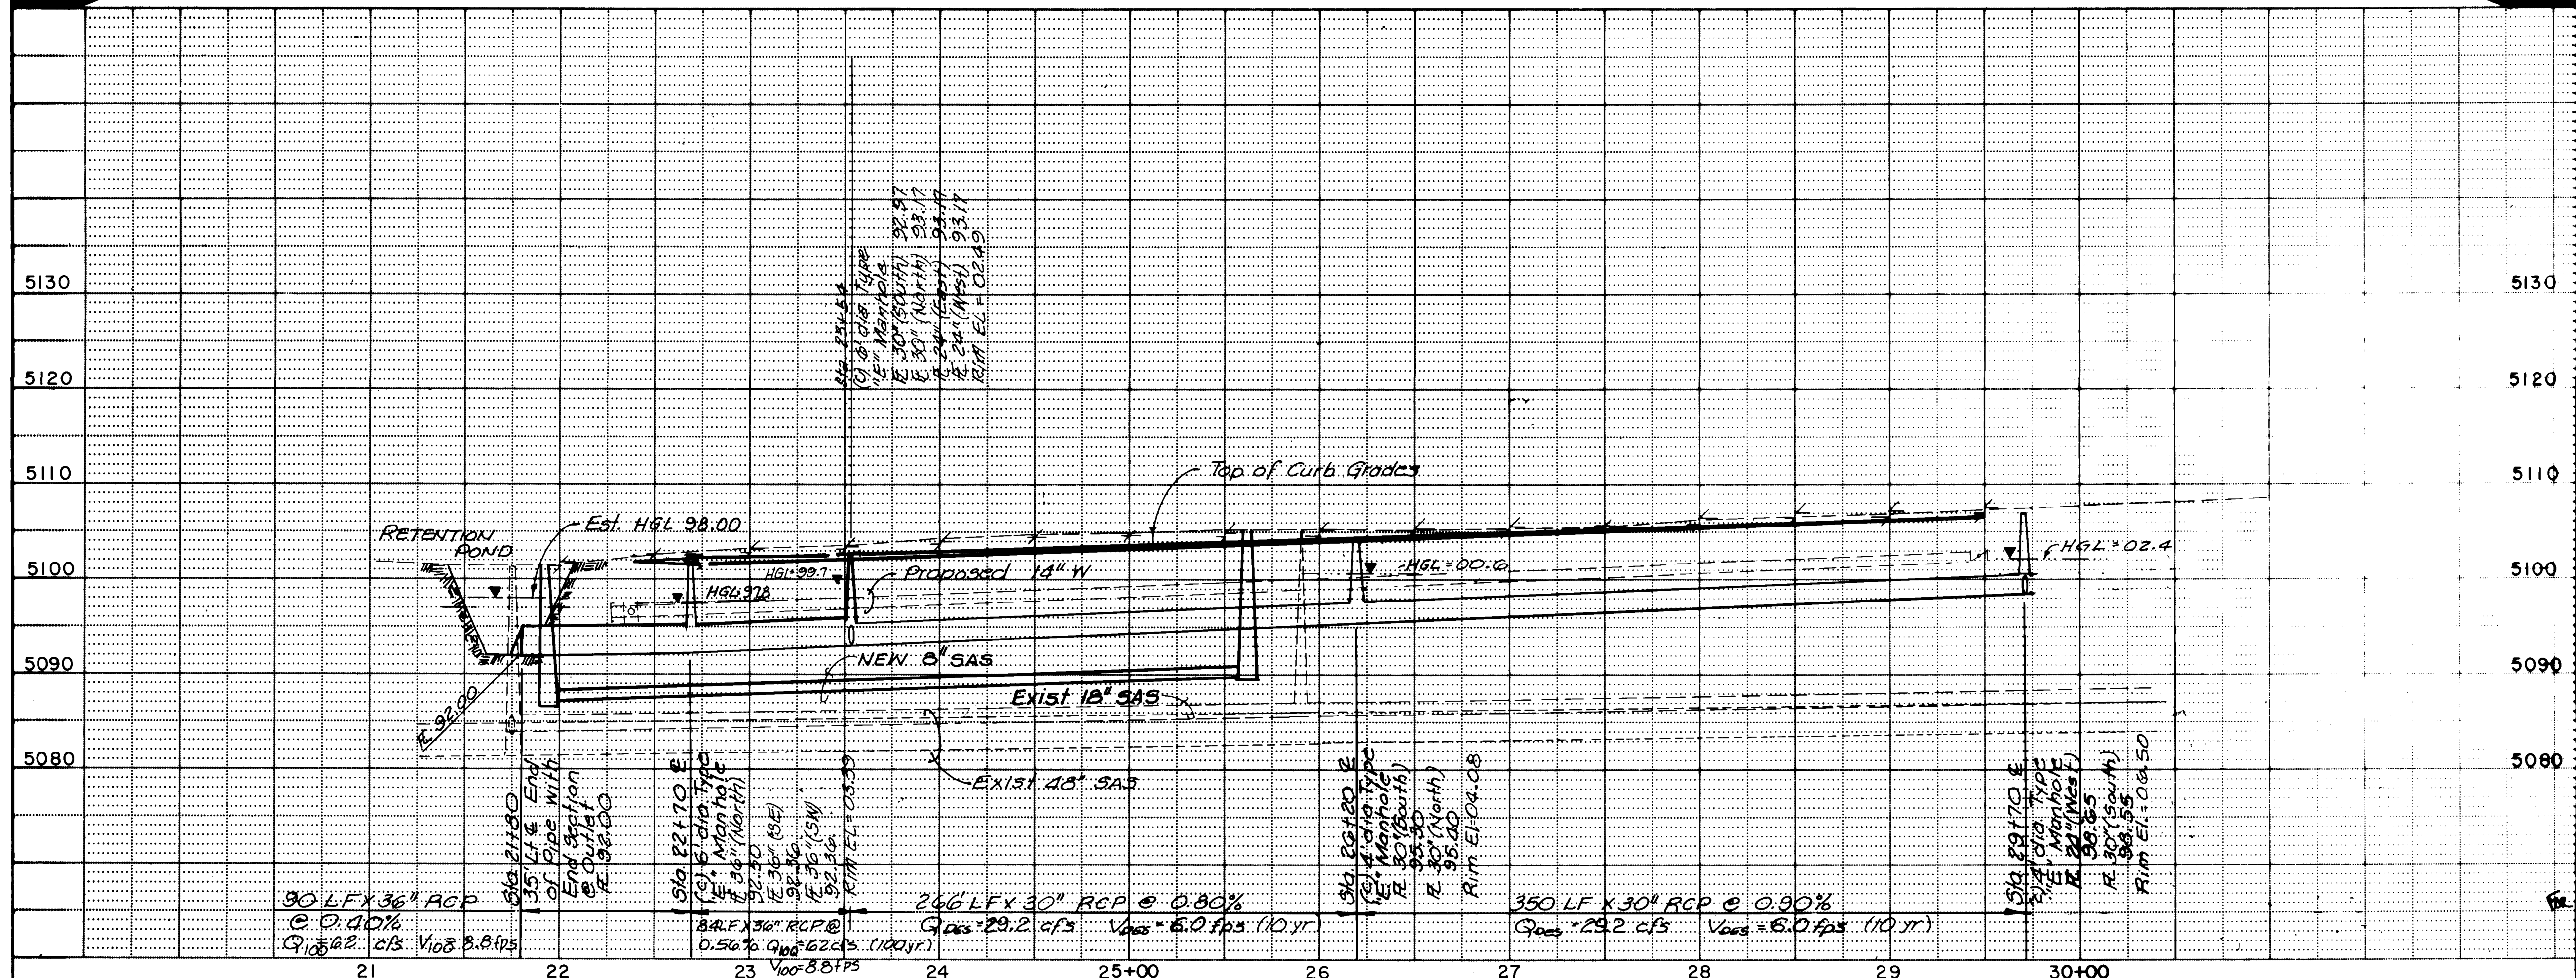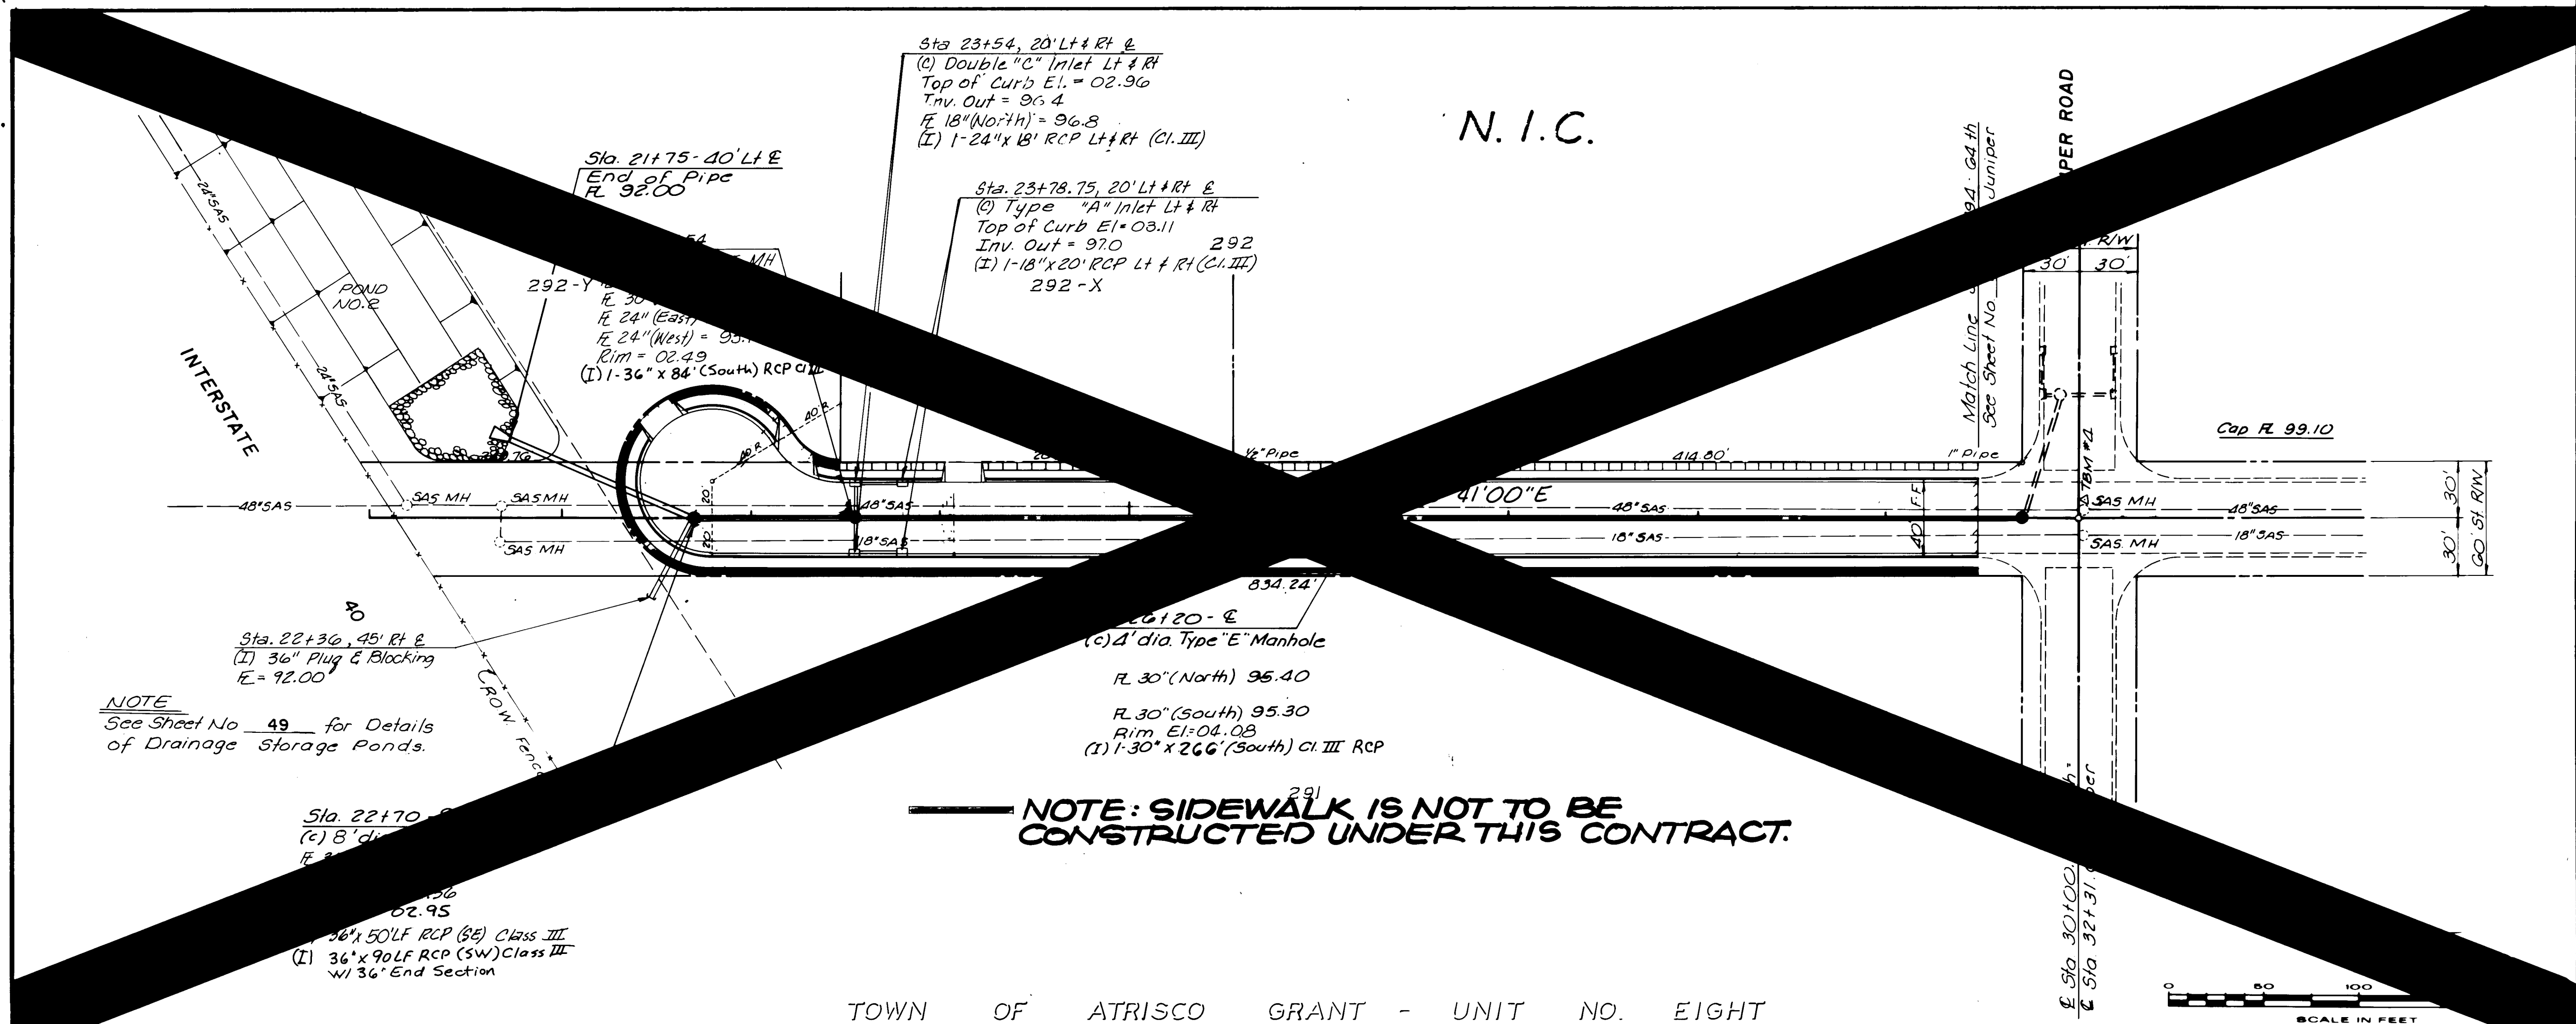

NOTE: SIDEWALK IS NOT TO BE CONSTRUCTED UNDER THIS CONTRACT.

AS BUILT INFORMATION		BENCH MARKS		SURVEY INFORMATION		ENGINEER'S SEAL	
CONTRACTOR	UNIVERSAL CONSTRUCTION	7BM #4 - Sta. 32+26 3' L.T. E	Juniper Road - + Cut on Manhole	FIELD NOTES	DATE		
STARTED BY	BMA	DATE	DATE	NO.	BY		
INSPECTOR'S	DATE	DATE	DATE	DATE	DATE	REVISIONS	
FILED	FILED	FILED	FILED	FILED	FILED		
VERIFICATION BY	GMA	DATE	DATE	DATE	DATE	WILSON & COMPANY, ENGINEERS & ARCHITECTS	
CORRECTED BY	WILSON & COMPANY	DATE	DATE	DATE	DATE		
RECORDED BY	DATE	DATE	DATE	DATE	DATE	DESIGNED BY	
NO	NO	NO	NO	NO	NO		

26 32294790

STORM DRAIN

CITY OF ALBUQUERQUE
PUBLIC WORKS DEPARTMENT
SPECIAL ASSESSMENT DISTRICT NO. 218


64th STREET

APPROVALS	ENGINEER	DATE	APPROVALS	ENGINEER	DATE
City Engineer	Reginald	3-14-89	Liquid Waste	Reginald	3/14/89
A-E-Design	u	11	Traffic	Reginald	3/14/89
A-E-Hydrology	CAM	3-7-89	Water	Reginald	3/14/89

DRAWING NO. 3229 MAP NO. H-10 & J-10 SHEET 47 OF 52

RECORD DRAWING
DATE 3-1-90

GARDNER, MASON & ASSOCIATES, INC.
ENGINEERS & PLANNERS
ALBUQUERQUE, N.M.
WILSON & COMPANY
ENGINEERS & ARCHITECTS
ALBUQUERQUE, NEW MEXICO
87-514

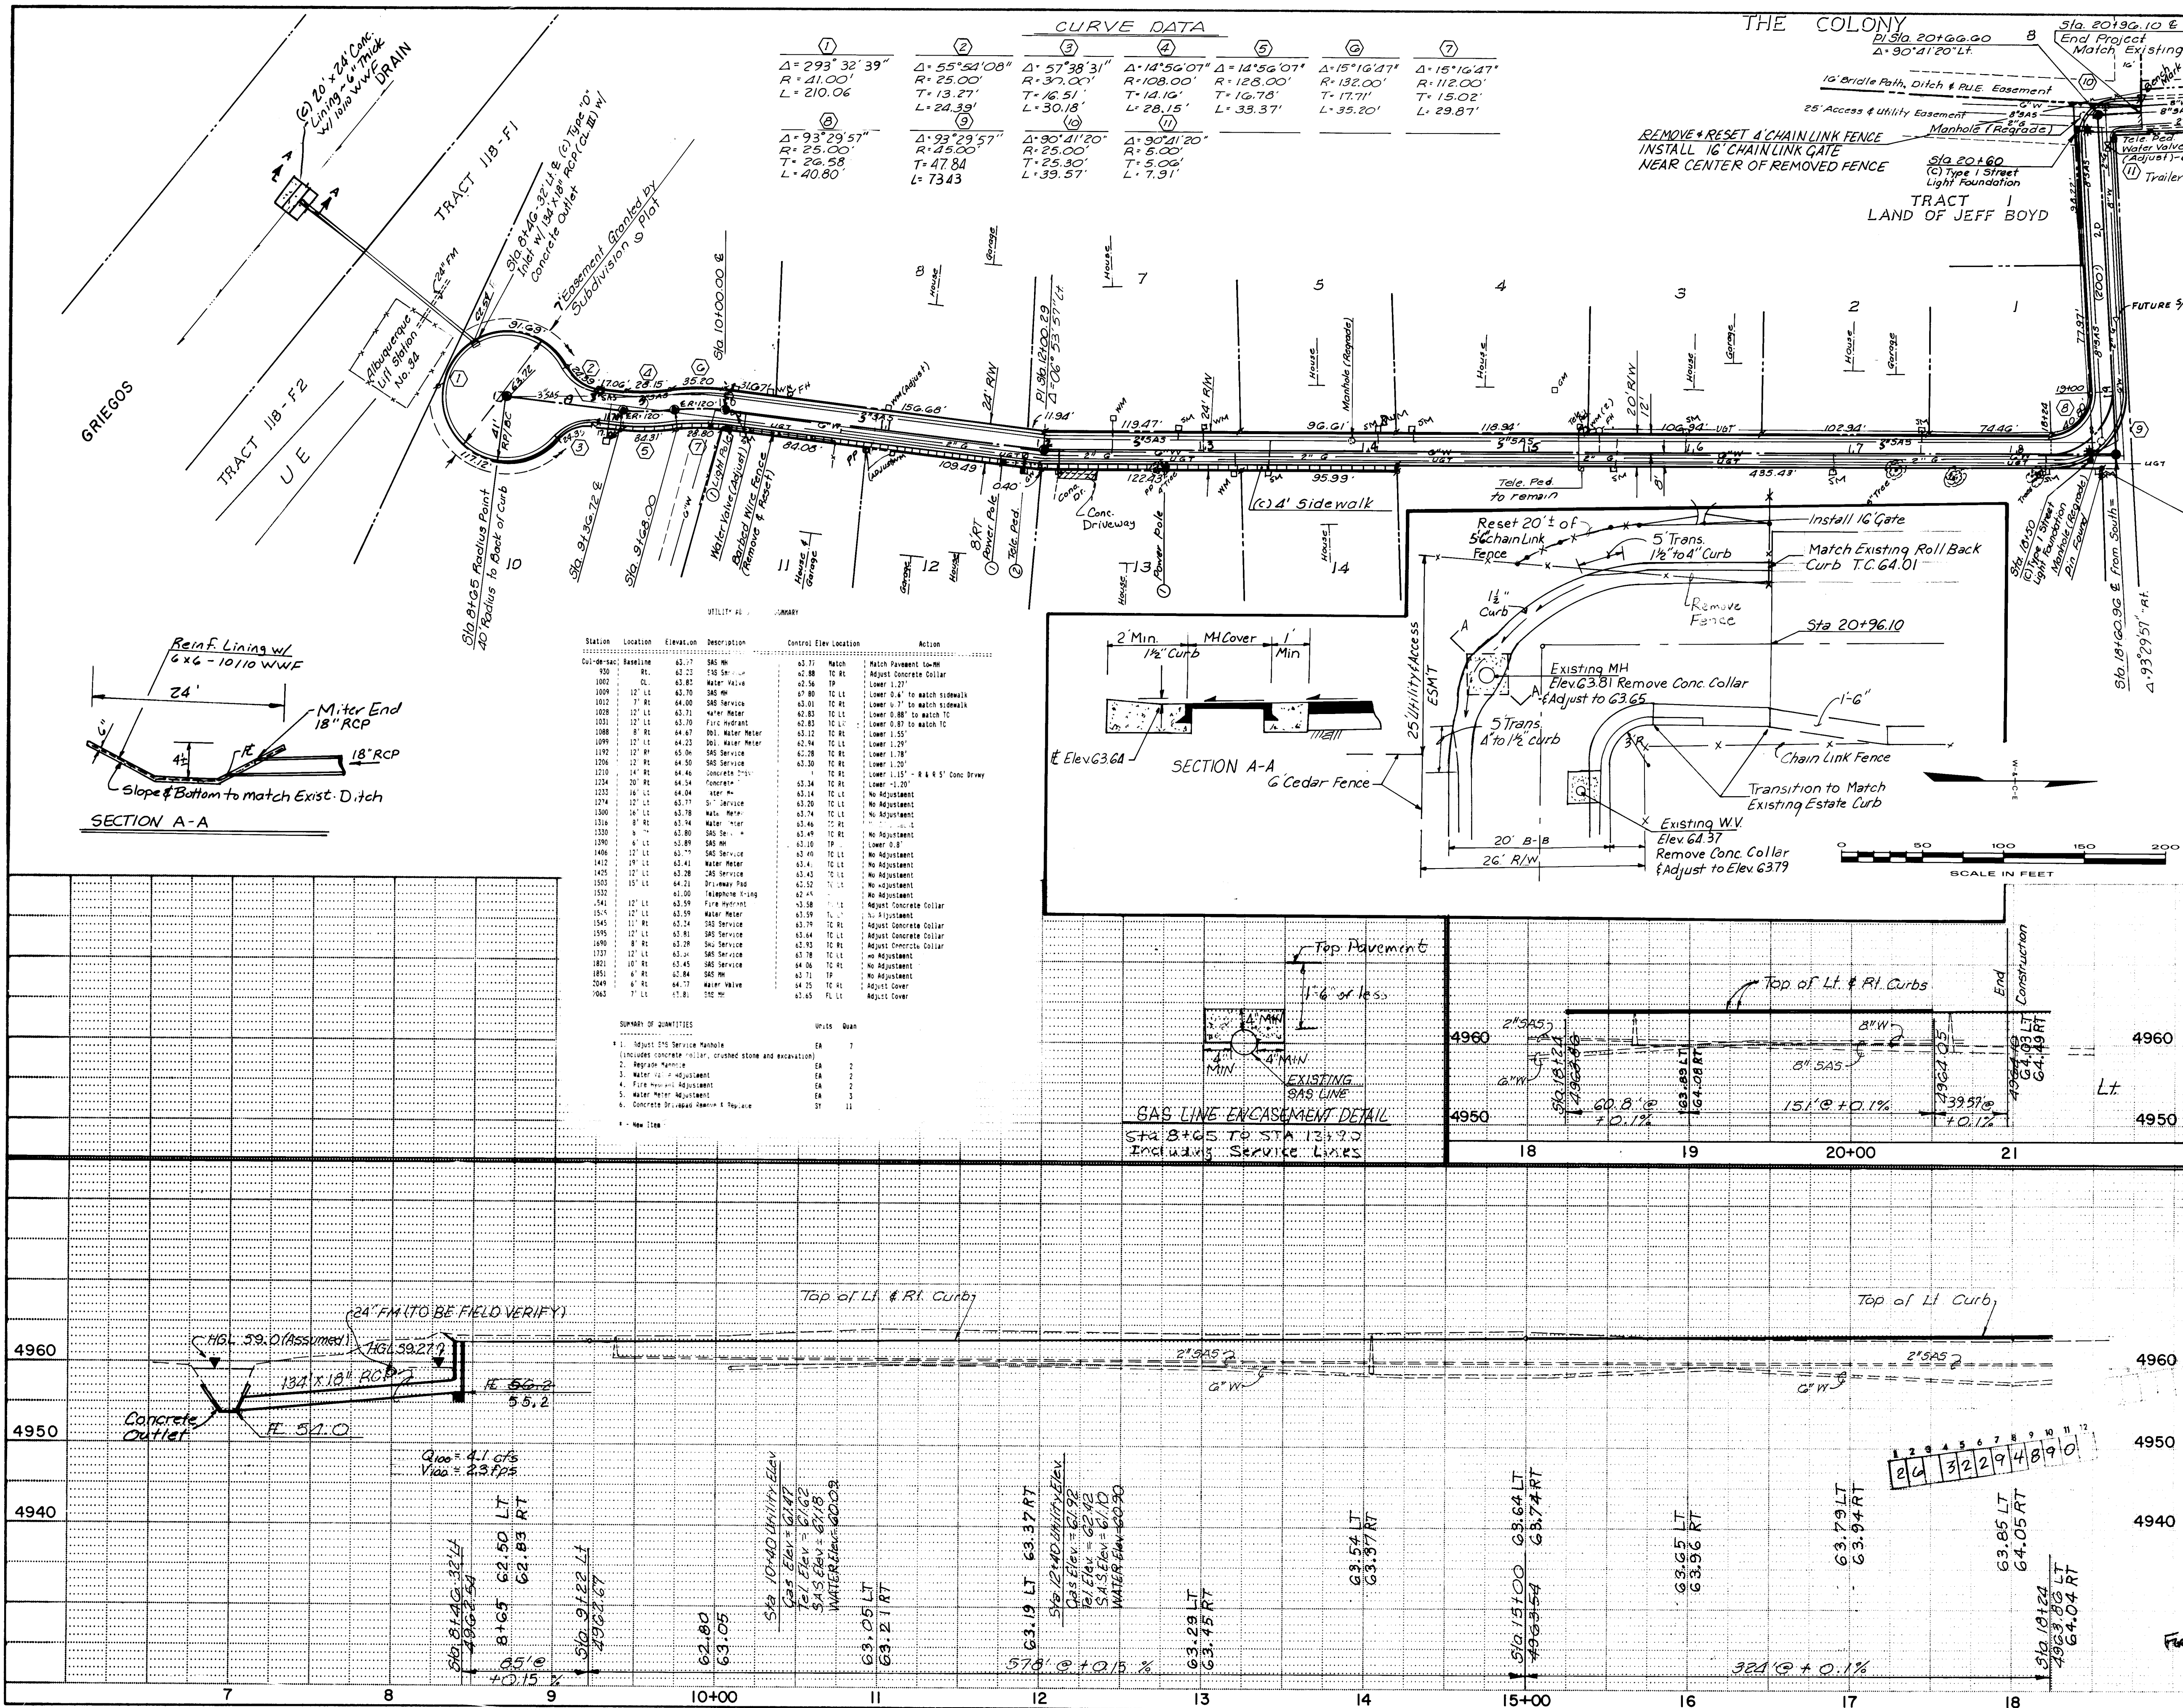

NOTE

- Power or Light Pole to be relocated by others.
- Telephone Pedestal to be relocated by others.
- All curve data is to back of curb.

(1) Pullbox & Riser
See PNM Detail
DS-4-10-0 Sheet 52.

ACS BRASS CAP "6-G13A"
X = 375.498.02
Y = 1,500,656.54
CENTRAL ZONE
Δα = 0° 00' 14.55"
G1G = 0.9996802

LEGEND

- Electrical Conduit
- Residential Light Std. Base & Luminaire
- Exist. Powerpole
- Water Meter
- Fire Hydrant
- (I) Install
- (C) Construct

VICINITY MAP G-13

PAVING & STORM DRAIN

CITY OF ALBUQUERQUE
PUBLIC WORKS DEPARTMENT
SPECIAL ASSESSMENT DISTRICT NO. 218

INDIAN FARM LANE

APPROVALS
City Engineer: [Signature]
Design: [Signature]
Hydrology: CAM

DATE: 3-11-97

REVISIONS
NO. DATE BY

REMARKS
9-14-88 Revised
6-10-89 REVISED




DRAWING NO. **3229**
MAP NO. G-13
SHEET **48** OF **52**

RECORD DRAWING
DATE 3-1-90


GARDNER, MASON & ASSOCIATES, INC.
ENGINEERS & PLANNERS
ALBUQUERQUE, N.M.

WILSON & COMPANY
ENGINEERS & ARCHITECTS
ALBUQUERQUE, NEW MEXICO

87-514

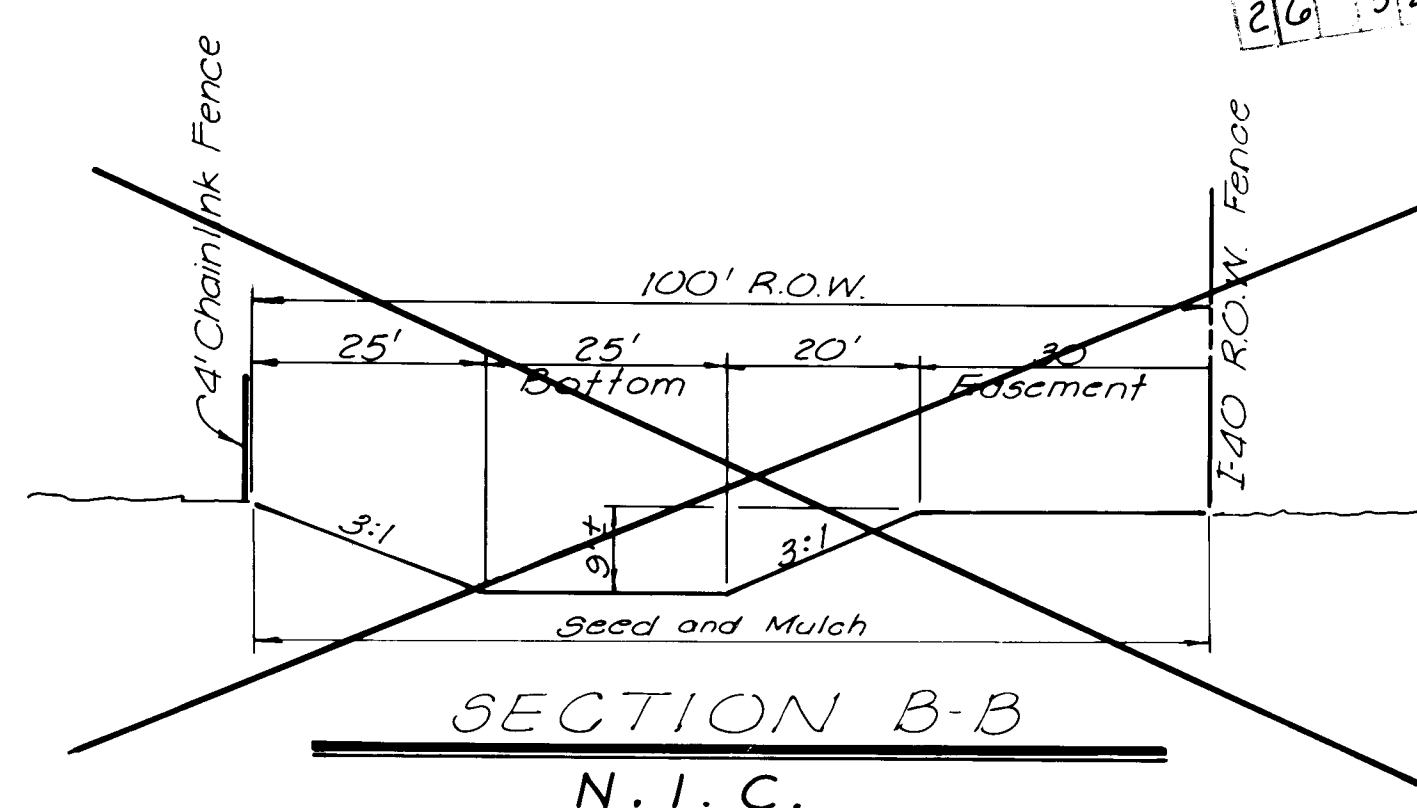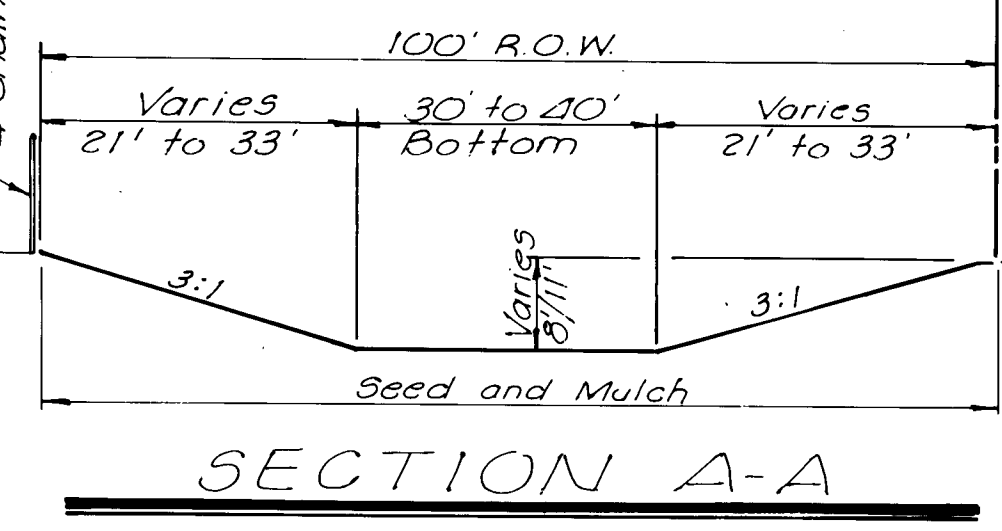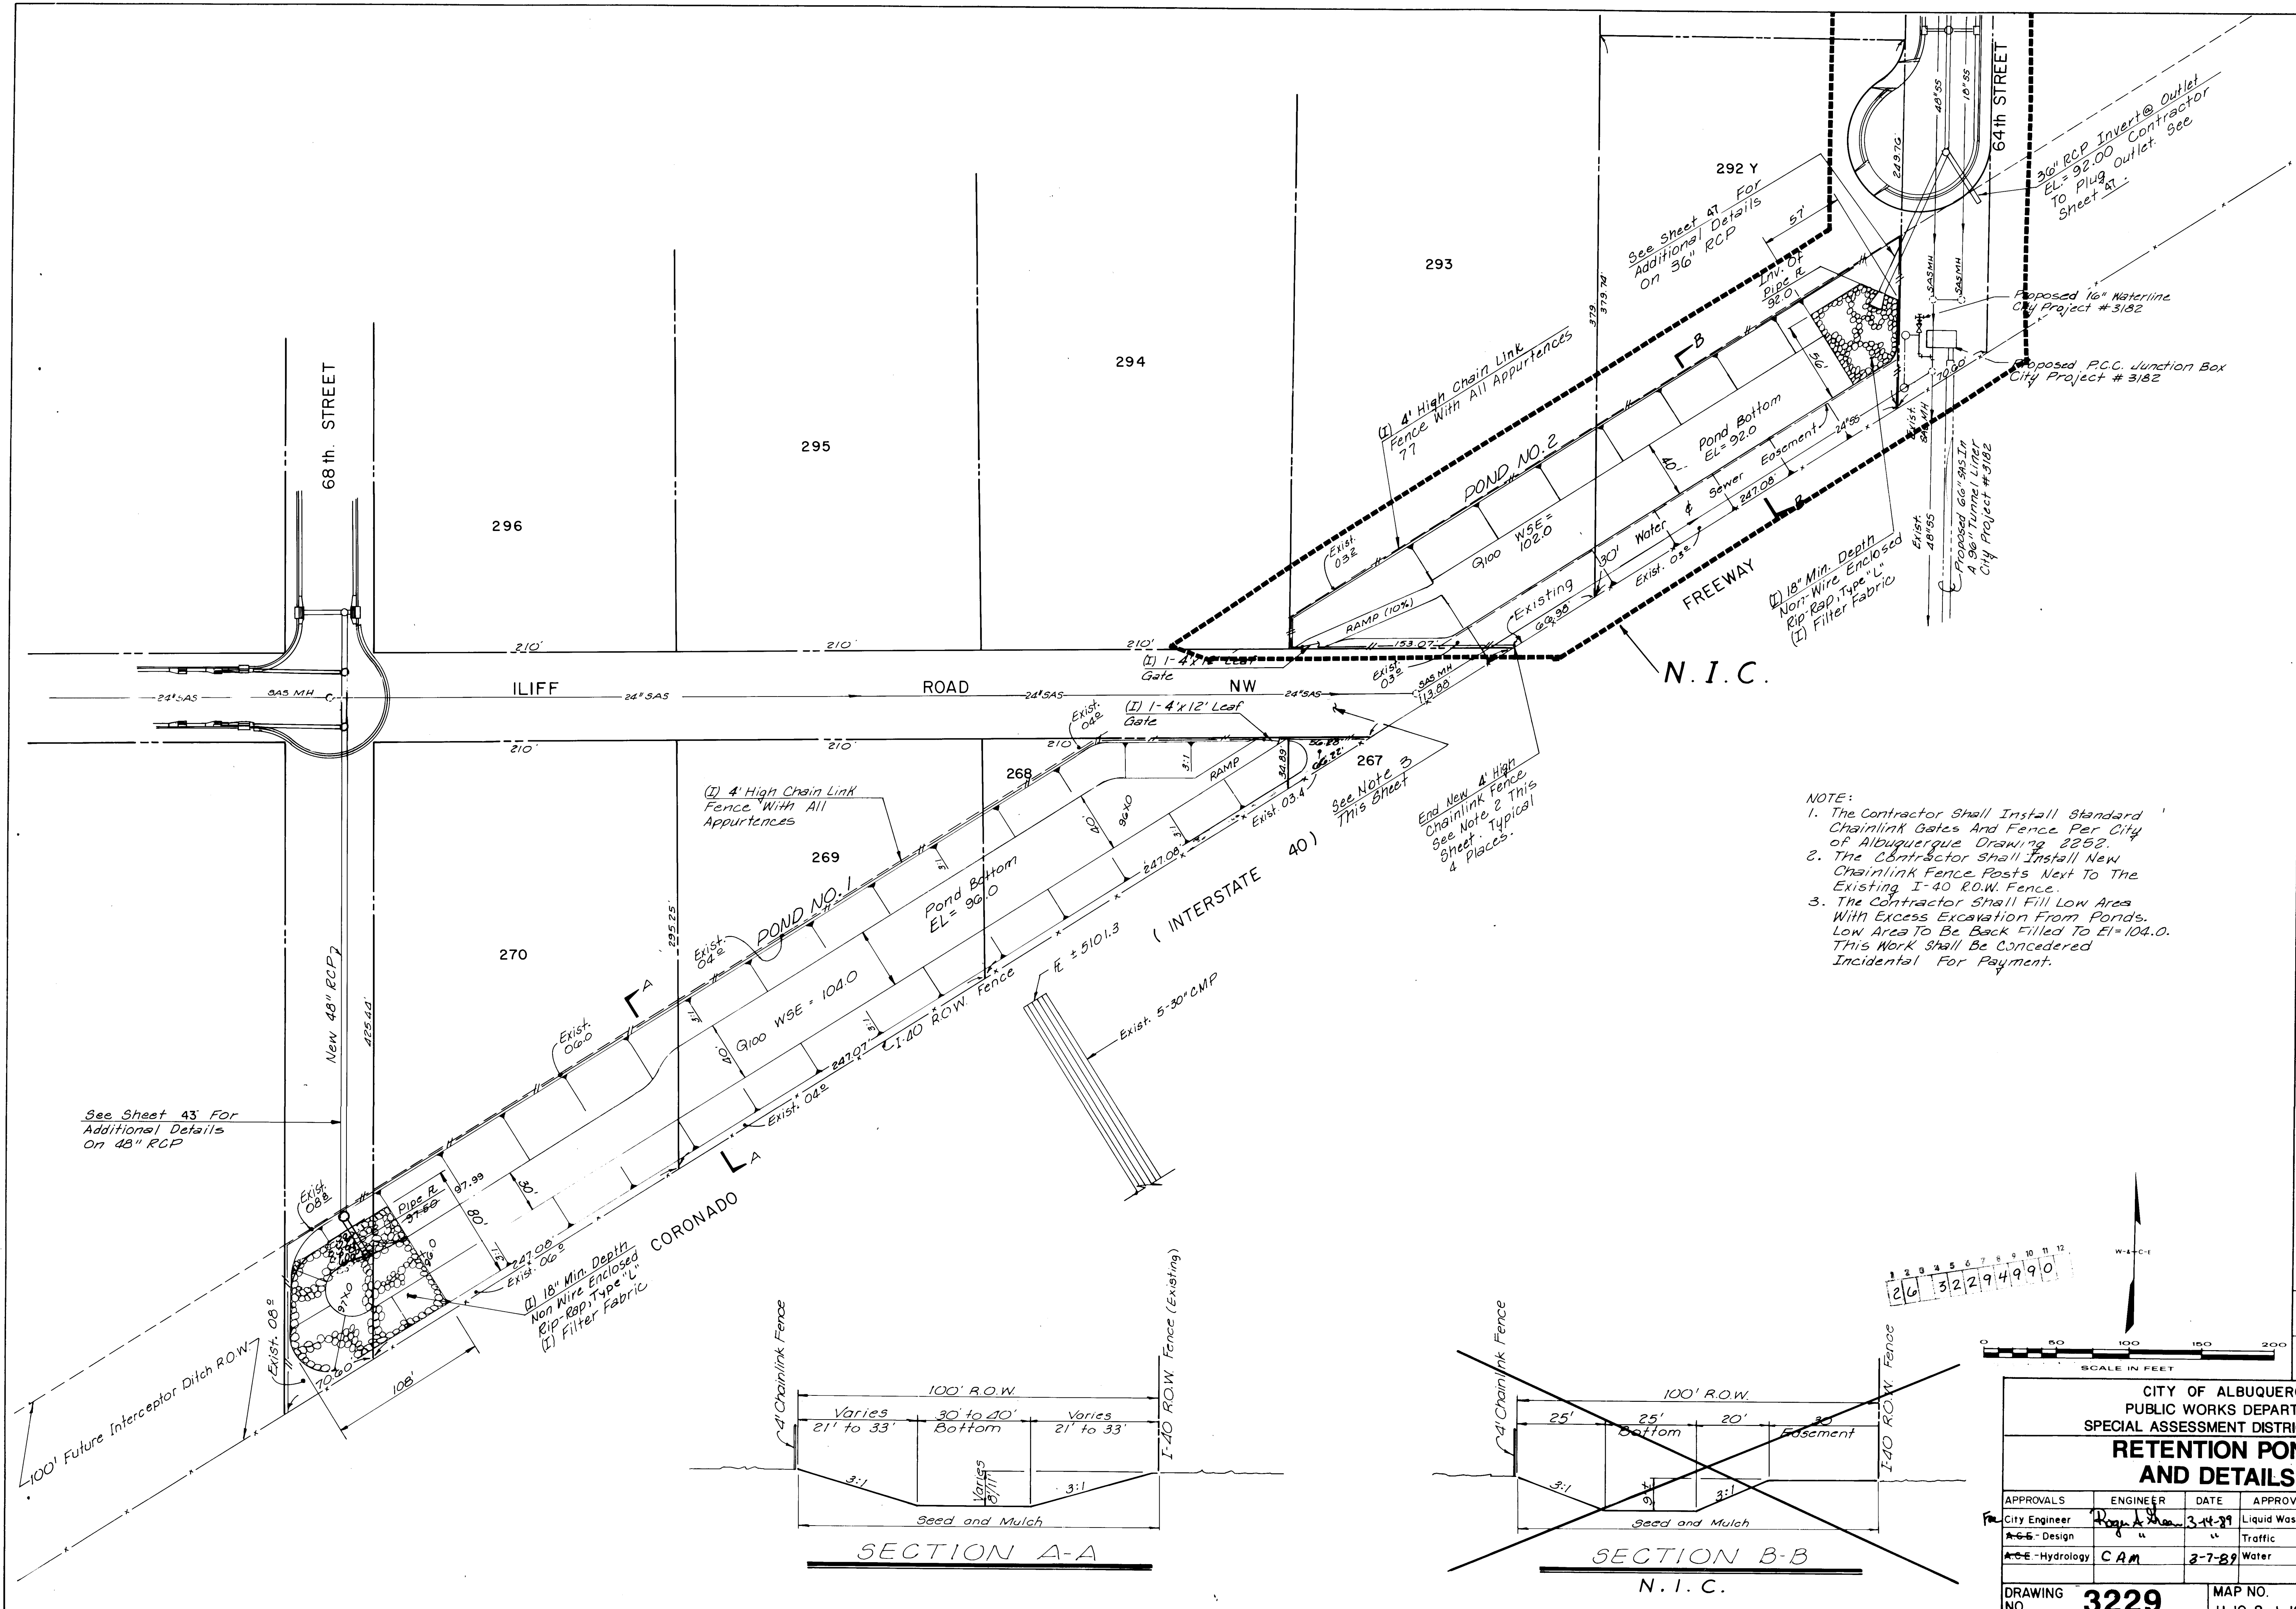


- NOTE:
1. The Contractor Shall Install Standard Chainlink Gates And Fence Per City of Albuquerque Drawing 2252.
 2. The Contractor Shall Install New Chainlink Fence Posts Next To The Existing I-40 R.O.W. Fence.
 3. The Contractor Shall Fill Low Area With Excess Excavation From Ponds. Low Area To Be Back Filled To El=104.0. This Work Shall Be Considered Incidental For Payment.


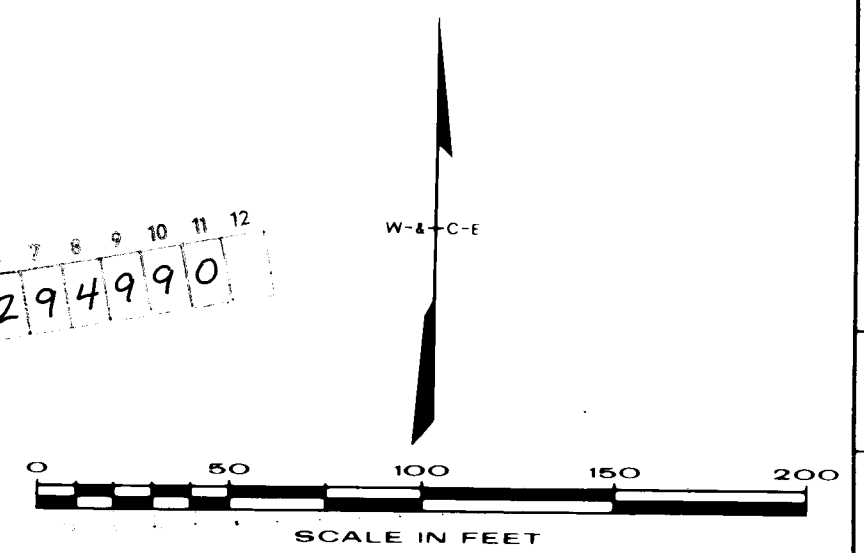


CITY OF ALBUQUERQUE PUBLIC WORKS DEPARTMENT SPECIAL ASSESSMENT DISTRICT NO. 218					
RETENTION PONDS AND DETAILS					
APPROVALS	ENGINEER	DATE	APPROVALS	ENGINEER	DATE
City Engineer	Robert J. ...	3-1-90	Liquid Waste	REDO	3/6/89
DESIGN	"	"	Traffic	REDO	3-14-89
Hydrology	CAM	3-7-89	Water	REDO	3/6/89
DRAWING NO.	3229		MAP NO.	H-10 & J-10	
SHEET 49			OF 52		

ENGINEER'S SEAL			SURVEY INFORMATION		BENCH MARKS		AS BUILT INFORMATION	
			FIELD NOTES		TBM #4 Sta. 3+72.6, 3' L.H. From Q. Luniper Road "+ " Cut On MH Rim. El. = 5108.91		CONTRACTOR UNIVERSAL CONSTRUCTION	
			NO.	BY	DATE	WORK ORDER		
						DATE 6-89		
						DATE 2-90		
							FIELD VERIFICATION BY GMA DATE 12-89	
							CORRECTED BY WILSON S CO DATE 3-90	
							MICRO-FILM INFORMATION	
							RECORDED BY DATE	
							NO	

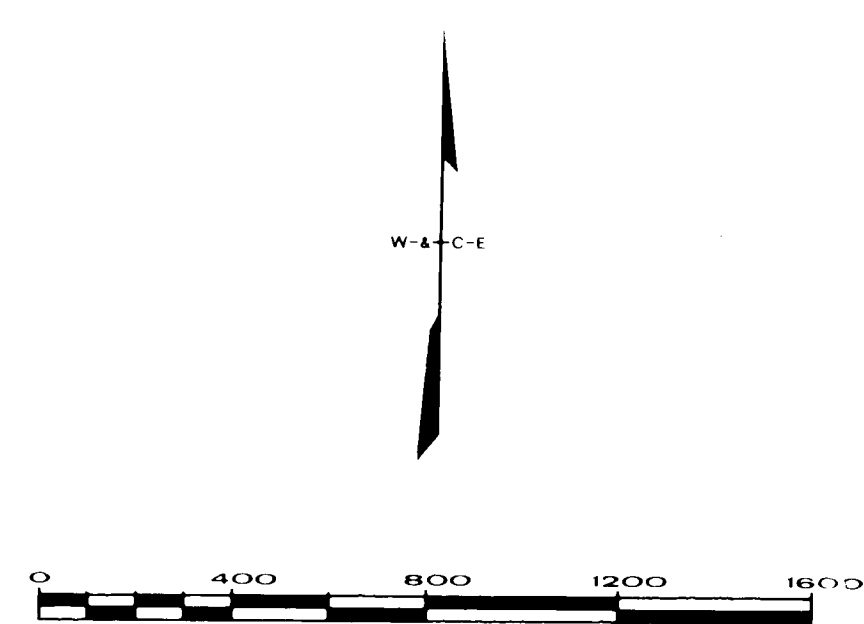

- LEGEND**
- 28'-6" Std. Pole & Luminaire (250')
 - Exist. Pole & Luminaire
 - Exist. Wood Pole w/ Luminaire (250')
 - Exist. Wood Pole
 - Pull-Box
 - 2" Elec. Conduit (250') Distance (Estimated)
 - Transformer w/ Conductor & Service Conduit

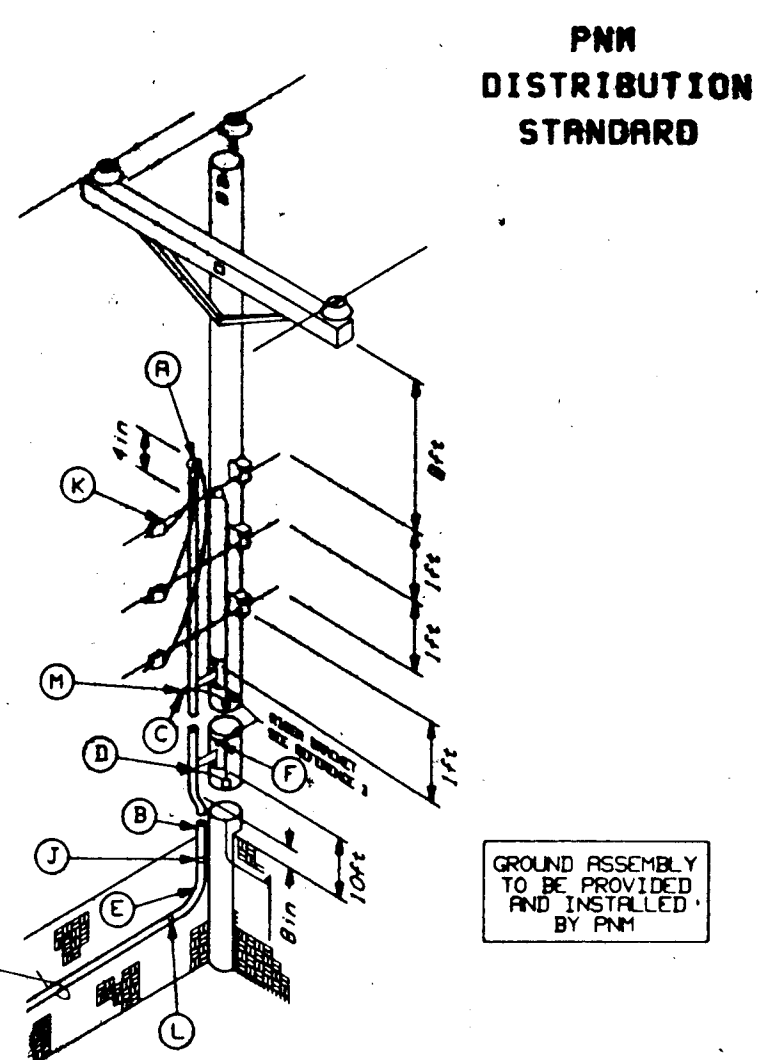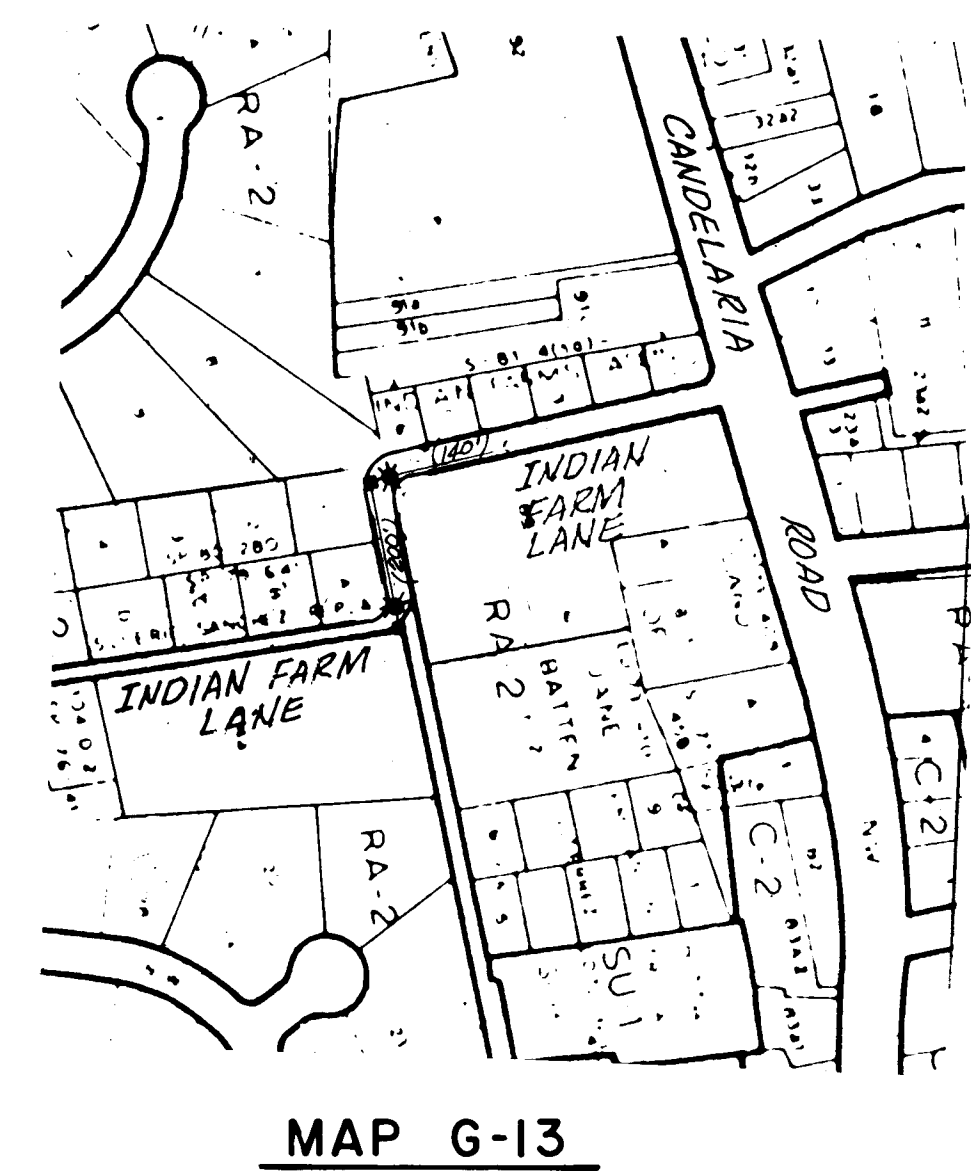

- NOTES**
- WEATHERING OF 4 IN. ABOVE NEUTRAL CONDUIT SHALL BE SUBJECT TO LOCAL CODES.
 - CONDUIT SHALL BE RIGID METALLIC OR GALVANIZED STEEL OR PLASTIC OR METALLIC.
 - CONDUIT SHALL BE RIGID METALLIC OR GALVANIZED STEEL OR PLASTIC OR METALLIC.
 - CONDUIT SHALL BE RIGID METALLIC OR GALVANIZED STEEL OR PLASTIC OR METALLIC.
 - CONDUIT SHALL BE RIGID METALLIC OR GALVANIZED STEEL OR PLASTIC OR METALLIC.
 - CONDUIT SHALL BE RIGID METALLIC OR GALVANIZED STEEL OR PLASTIC OR METALLIC.
 - CONDUIT SHALL BE RIGID METALLIC OR GALVANIZED STEEL OR PLASTIC OR METALLIC.

ITEM	QUANTITY	DESCRIPTION	STOCK NO.
1	1	2 1/2" CLAMP TYP. WEATHER HD	5875-263277
2	1	2 1/2" GALVANIZED CONDUIT	5875-257857
3	1	2 1/2" GALVANIZED CONDUIT	5875-257857
4	1	2 1/2" GALVANIZED CONDUIT	5875-257857
5	1	2 1/2" GALVANIZED CONDUIT	5875-257857
6	1	2 1/2" GALVANIZED CONDUIT	5875-257857
7	1	2 1/2" GALVANIZED CONDUIT	5875-257857
8	1	2 1/2" GALVANIZED CONDUIT	5875-257857
9	1	2 1/2" GALVANIZED CONDUIT	5875-257857
10	1	2 1/2" GALVANIZED CONDUIT	5875-257857

SINGLE PHASE PEDESTAL METERING DS-4-10.0 12/78

- NOTE.**
- The pay length of electrical conduit shall be from E of pole to E of pole and measured thru the pull box.
 - The contractor to construct the Street Light Foundation per C.O.A. Drawing 2530, Type I.
 - The contractor shall install 2" PVC schedule 40 and 2" galvanized conduit per PNM Std. Dng. DS-4-10.0.
 - All 2" Conduit installed in this contract shall include the pull wire.
 - PNM is to install all street lights. All electrical work shall be done Per PNM standards. Contact Steve Casey (PNM) 848-2460.

AS BUILT INFORMATION		BENCH MARKS		SURVEY INFORMATION		ENGINEER'S SEAL	
CONTRACTOR	UNIVERSAL CONSTRUCTION	NO.	DATE	NO.	DATE	[Signature]	
WORK BY	SHA	NO.	DATE	NO.	DATE	[Signature]	
INSPECTED BY	SHA	NO.	DATE	NO.	DATE	[Signature]	
ASPECTANCE BY	R. HAWLEY	NO.	DATE	NO.	DATE	[Signature]	
FIELD DRAWING BY	SHA	NO.	DATE	NO.	DATE	[Signature]	
CONDUCTED BY	WILSON & COMPANY	NO.	DATE	NO.	DATE	[Signature]	
RECORDED BY	DATE	NO.	DATE	NO.	DATE	[Signature]	

26 3229 51 90

CITY OF ALBUQUERQUE
PUBLIC WORKS DEPARTMENT
SPECIAL ASSESSMENT DISTRICT NO. 218

LIGHTING PLAN

APPROVALS	ENGINEER	DATE	APPROVALS	ENGINEER	DATE
City Engineer	Don L. Shaw	3-14-89	Liquid Waste	Don L. Shaw	3-14-89
A-E-Design	Don L. Shaw	3-14-89	Traffic	Don L. Shaw	3-14-89
A-E-Hydrology	CAM PA	3-7-89	Water	Don L. Shaw	3-14-89

DRAWING NO. 3229 MAP NO. H-10 & J-10 SHEET 51 OF 52

RECORD DRAWING
DATE 3-1-90

WILSON & COMPANY
ENGINEERS & ARCHITECTS
ALBUQUERQUE NEW MEXICO

