


98TH ST. MASTERPLAN

30" WATER LINE

WATER LINE CONSTRUCTION PLANS FOR UTILITY DEVELOPMENT DIVISION CITY OF ALBUQUERQUE

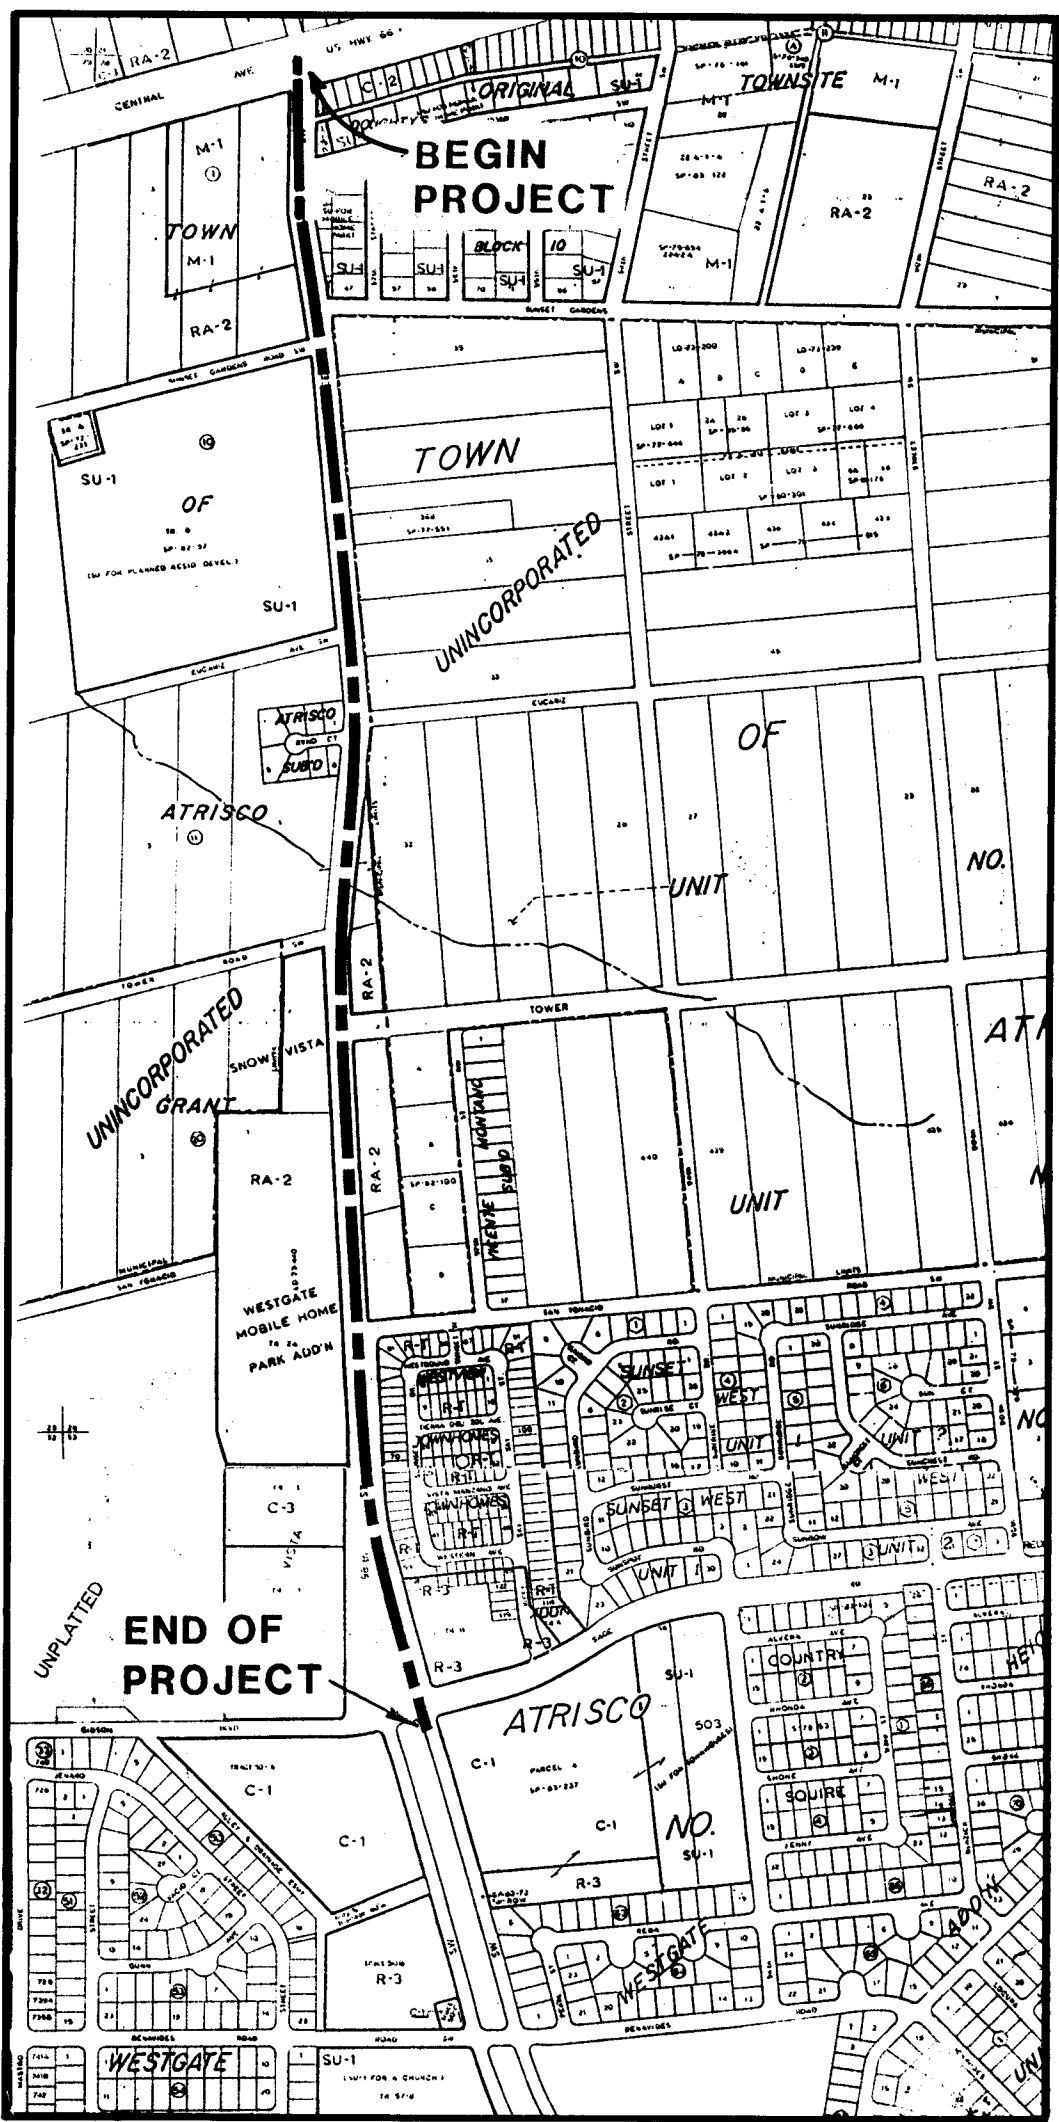

ZONE ATLAS: L-9 & M-9 SCALE: 1"=750'±

LOCATION MAP

NOTES

1. CONTRACTOR SHALL COORDINATE CLOSURE OF EXISTING VALVES AND REQUIRED TIE-INS WITH THE WATER SYSTEMS DIVISION OF THE CITY OF ALBUQUERQUE BY CALLING EITHER 823-4200 OR 768-2730 A MINIMUM OF FIVE (5) WORKING DAYS PRIOR TO ANY PLANNED CONSTRUCTION.
2. CONTRACTOR SHALL CONDUCT WORK IN SUCH A WAY THAT TRAFFIC ON 98TH STREET IS SAFELY ROUTED AROUND THE AREA(S) AFFECTED BY CONSTRUCTION. PARKED VEHICLES AND STORED EQUIPMENT & MATERIALS WILL NOT BE ALLOWED WITHIN 15 FEET OF TRAFFIC LANES OF 98TH STREET. ALL REQUIRED WARNING AND CAUTIONARY SIGNS SHALL BE IN ACCORDANCE WITH THE MANUAL ON UNIFORM TRAFFIC CONTROL DEVICES.
3. TWO (2) WORKING DAYS PRIOR TO ANY EXCAVATION, CONTRACTOR MUST CONTACT LINE LOCATING SERVICE, 765-1234, FOR LOCATION OF EXISTING UTILITIES.
4. PRIOR TO CONSTRUCTION, THE CONTRACTOR SHALL EXCAVATE AND VERIFY THE HORIZONTAL AND VERTICAL LOCATIONS OF ALL OBSTRUCTIONS. SHOULD A CONFLICT EXIST, THE CONTRACTOR SHALL NOTIFY THE ENGINEER OR SURVEYOR SO THAT THE CONFLICT CAN BE RESOLVED WITH MINIMUM AMOUNT OF DELAY.
5. ALL WORK DETAILED ON THESE PLANS TO BE PERFORMED UNDER CONTRACT SHALL, EXCEPT AS OTHERWISE STATED OR PROVIDED FOR HEREON, BE CONSTRUCTED IN ACCORDANCE WITH THE CITY OF ALBUQUERQUE STANDARD SPECIFICATIONS FOR PUBLIC WORKS CONSTRUCTION 1986.

INDEX


1. TITLE SHEET & VICINITY MAP
2. MASTER UTILITY PLAN
3. WATER VALVE SHUT-OFF PLAN
- 4.-9. PLAN & PROFILE SHEETS
10. WATER LINE DETAILS
11. TRAFFIC CONTROL DETAILS & NOTES

For *[Signature]* 6/14/81
1 2 3 4 5 6 7 8 9 10 11 12
26 33 77 01 89

AS-BUILT 11-18-88

REV.	SHEETS	CITY ENGR.	DATE	USER DEPT.	DATE	USER DEPT.	DATE
APPROVAL OF REVISIONS							

	Isaacson & Arfman, P.A. CONSULTING ENGINEERING ASSOCIATES Albuquerque, New Mexico		APPROVED FOR CONSTRUCTION <i>[Signature]</i> 4/5/88
	PROJECT NO. 3377		SHEET 1 OF 11

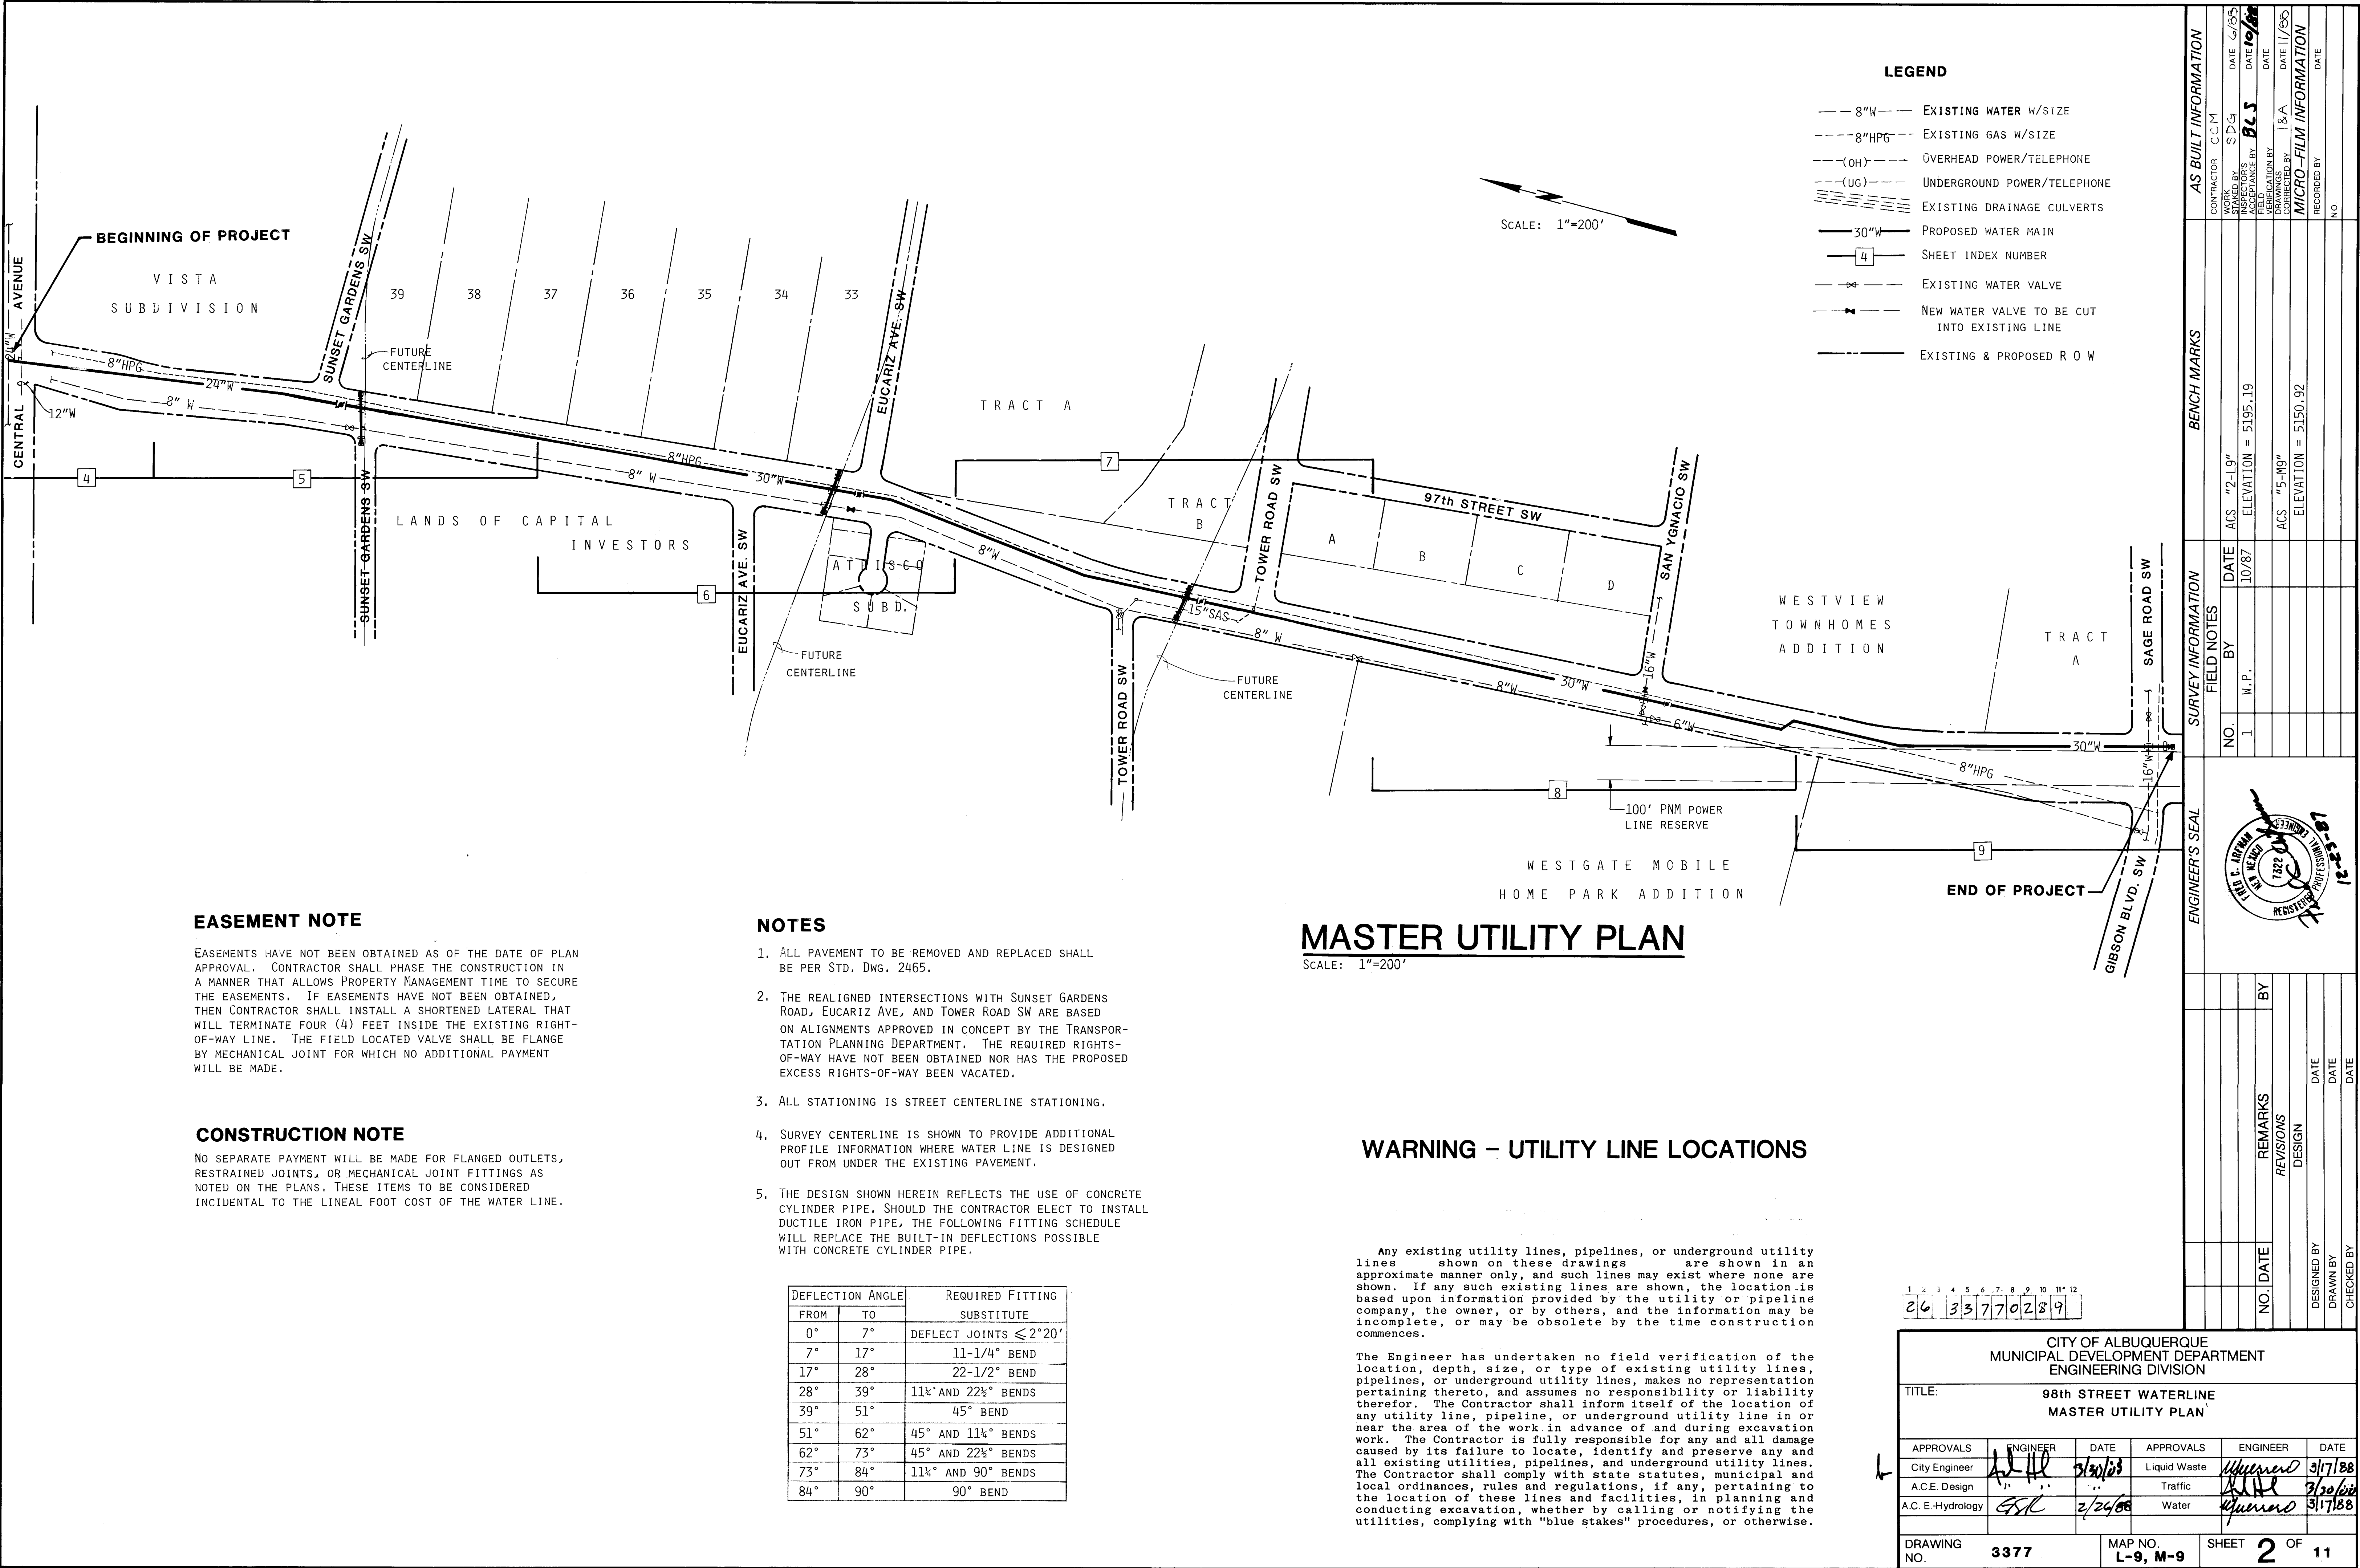

EASEMENT NOTE

EASEMENTS HAVE NOT BEEN OBTAINED AS OF THE DATE OF PLAN APPROVAL. CONTRACTOR SHALL PHASE THE CONSTRUCTION IN A MANNER THAT ALLOWS PROPERTY MANAGEMENT TIME TO SECURE THE EASEMENTS. IF EASEMENTS HAVE NOT BEEN OBTAINED, THEN CONTRACTOR SHALL INSTALL A SHORTENED LATERAL THAT WILL TERMINATE FOUR (4) FEET INSIDE THE EXISTING RIGHT-OF-WAY LINE. THE FIELD LOCATED VALVE SHALL BE FLANGE BY MECHANICAL JOINT FOR WHICH NO ADDITIONAL PAYMENT WILL BE MADE.

CONSTRUCTION NOTE

NO SEPARATE PAYMENT WILL BE MADE FOR FLANGED OUTLETS, RESTRAINED JOINTS, OR MECHANICAL JOINT FITTINGS AS NOTED ON THE PLANS. THESE ITEMS TO BE CONSIDERED INCIDENTAL TO THE LINEAL FOOT COST OF THE WATER LINE.

NOTES

- ALL PAVEMENT TO BE REMOVED AND REPLACED SHALL BE PER STD. DWG. 2465.
- THE REALIGNED INTERSECTIONS WITH SUNSET GARDENS ROAD, EUCARIZ AVE, AND TOWER ROAD SW ARE BASED ON ALIGNMENTS APPROVED IN CONCEPT BY THE TRANSPORTATION PLANNING DEPARTMENT. THE REQUIRED RIGHTS-OF-WAY HAVE NOT BEEN OBTAINED NOR HAS THE PROPOSED EXCESS RIGHTS-OF-WAY BEEN VACATED.
- ALL STATIONING IS STREET CENTERLINE STATIONING.
- SURVEY CENTERLINE IS SHOWN TO PROVIDE ADDITIONAL PROFILE INFORMATION WHERE WATER LINE IS DESIGNED OUT FROM UNDER THE EXISTING PAVEMENT.
- THE DESIGN SHOWN HEREIN REFLECTS THE USE OF CONCRETE CYLINDER PIPE. SHOULD THE CONTRACTOR ELECT TO INSTALL DUCTILE IRON PIPE, THE FOLLOWING FITTING SCHEDULE WILL REPLACE THE BUILT-IN DEFLECTIONS POSSIBLE WITH CONCRETE CYLINDER PIPE.

DEFLECTION ANGLE		REQUIRED FITTING
FROM	TO	SUBSTITUTE
0°	7°	DEFLECT JOINTS ≤ 2° 20'
7°	17°	11-1/4° BEND
17°	28°	22-1/2° BEND
28°	39°	11¼° AND 22½° BENDS
39°	51°	45° BEND
51°	62°	45° AND 11¼° BENDS
62°	73°	45° AND 22½° BENDS
73°	84°	11¼° AND 90° BENDS
84°	90°	90° BEND

MASTER UTILITY PLAN

SCALE: 1"=200'

WARNING - UTILITY LINE LOCATIONS


Any existing utility lines, pipelines, or underground utility lines shown on these drawings are shown in an approximate manner only, and such lines may exist where none are shown. If any such existing lines are shown, the location is based upon information provided by the utility or pipeline company, the owner, or by others, and the information may be incomplete, or may be obsolete by the time construction commences.

The Engineer has undertaken no field verification of the location, depth, size, or type of existing utility lines, pipelines, or underground utility lines, makes no representation pertaining thereto, and assumes no responsibility or liability therefor. The Contractor shall inform itself of the location of any utility line, pipeline, or underground utility line in or near the area of the work in advance of and during excavation work. The Contractor is fully responsible for any and all damage caused by its failure to locate, identify and preserve any and all existing utilities, pipelines, and underground utility lines. The Contractor shall comply with state statutes, municipal and local ordinances, rules and regulations, if any, pertaining to the location of these lines and facilities, in planning and conducting excavation, whether by calling or notifying the utilities, complying with "blue stakes" procedures, or otherwise.

LEGEND


- 8"W EXISTING WATER W/SIZE
- 8"HPG EXISTING GAS W/SIZE
- (OH) OVERHEAD POWER/TELEPHONE
- (UG) UNDERGROUND POWER/TELEPHONE
- EXISTING DRAINAGE CULVERTS
- 30"W PROPOSED WATER MAIN
- 4 SHEET INDEX NUMBER
- EXISTING WATER VALVE
- NEW WATER VALVE TO BE CUT INTO EXISTING LINE
- EXISTING & PROPOSED R O W

AS BUILT INFORMATION				BENCH MARKS				SURVEY INFORMATION			
CONTRACTOR	C.C.M.	WORK BY	SDG	DATE	10/87	NO.	1	DATE	10/87	BY	M.P.
INSPECTED BY	BLJ	DATE	10/87	ELEVATION	5195.19	NO.	1	DATE	10/87	BY	M.P.
ACCEPTANCE BY	BLJ	DATE	10/87	ELEVATION	5150.92	NO.	1	DATE	10/87	BY	M.P.
VERIFICATION BY	1&A	DATE	11/87	ELEVATION	5150.92	NO.	1	DATE	10/87	BY	M.P.
DRAWINGS	1&A	DATE	11/87	ELEVATION	5150.92	NO.	1	DATE	10/87	BY	M.P.
REVISIONS	1&A	DATE	11/87	ELEVATION	5150.92	NO.	1	DATE	10/87	BY	M.P.
MICRO-FILM INFORMATION				RECORDING INFORMATION				REVISIONS			
RECORDED BY	NO.	DATE		RECORDED BY	NO.	DATE		DESIGNED BY	DATE	DRAWN BY	DATE
								CHECKED BY	DATE		DATE

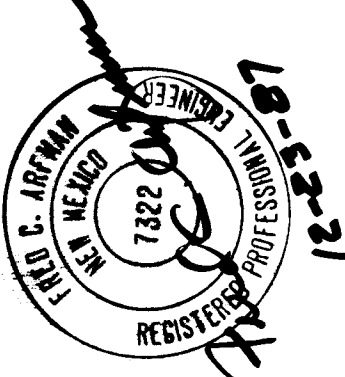

1	2	3	4	5	6	7	8	9	10	11	12
26	33	77	02	89							

CITY OF ALBUQUERQUE MUNICIPAL DEVELOPMENT DEPARTMENT ENGINEERING DIVISION					
TITLE: 98th STREET WATERLINE MASTER UTILITY PLAN					
APPROVALS	ENGINEER	DATE	APPROVALS	ENGINEER	DATE
City Engineer	3/30/88	3/30/88	Liquid Waste	3/17/88	3/17/88
A.C.E. Design	3/30/88	3/30/88	Traffic	3/30/88	3/30/88
A.C. E.-Hydrology	3/30/88	3/30/88	Water	3/17/88	3/17/88
DRAWING NO.	3377	MAP NO.	L-9, M-9	SHEET	2 OF 11

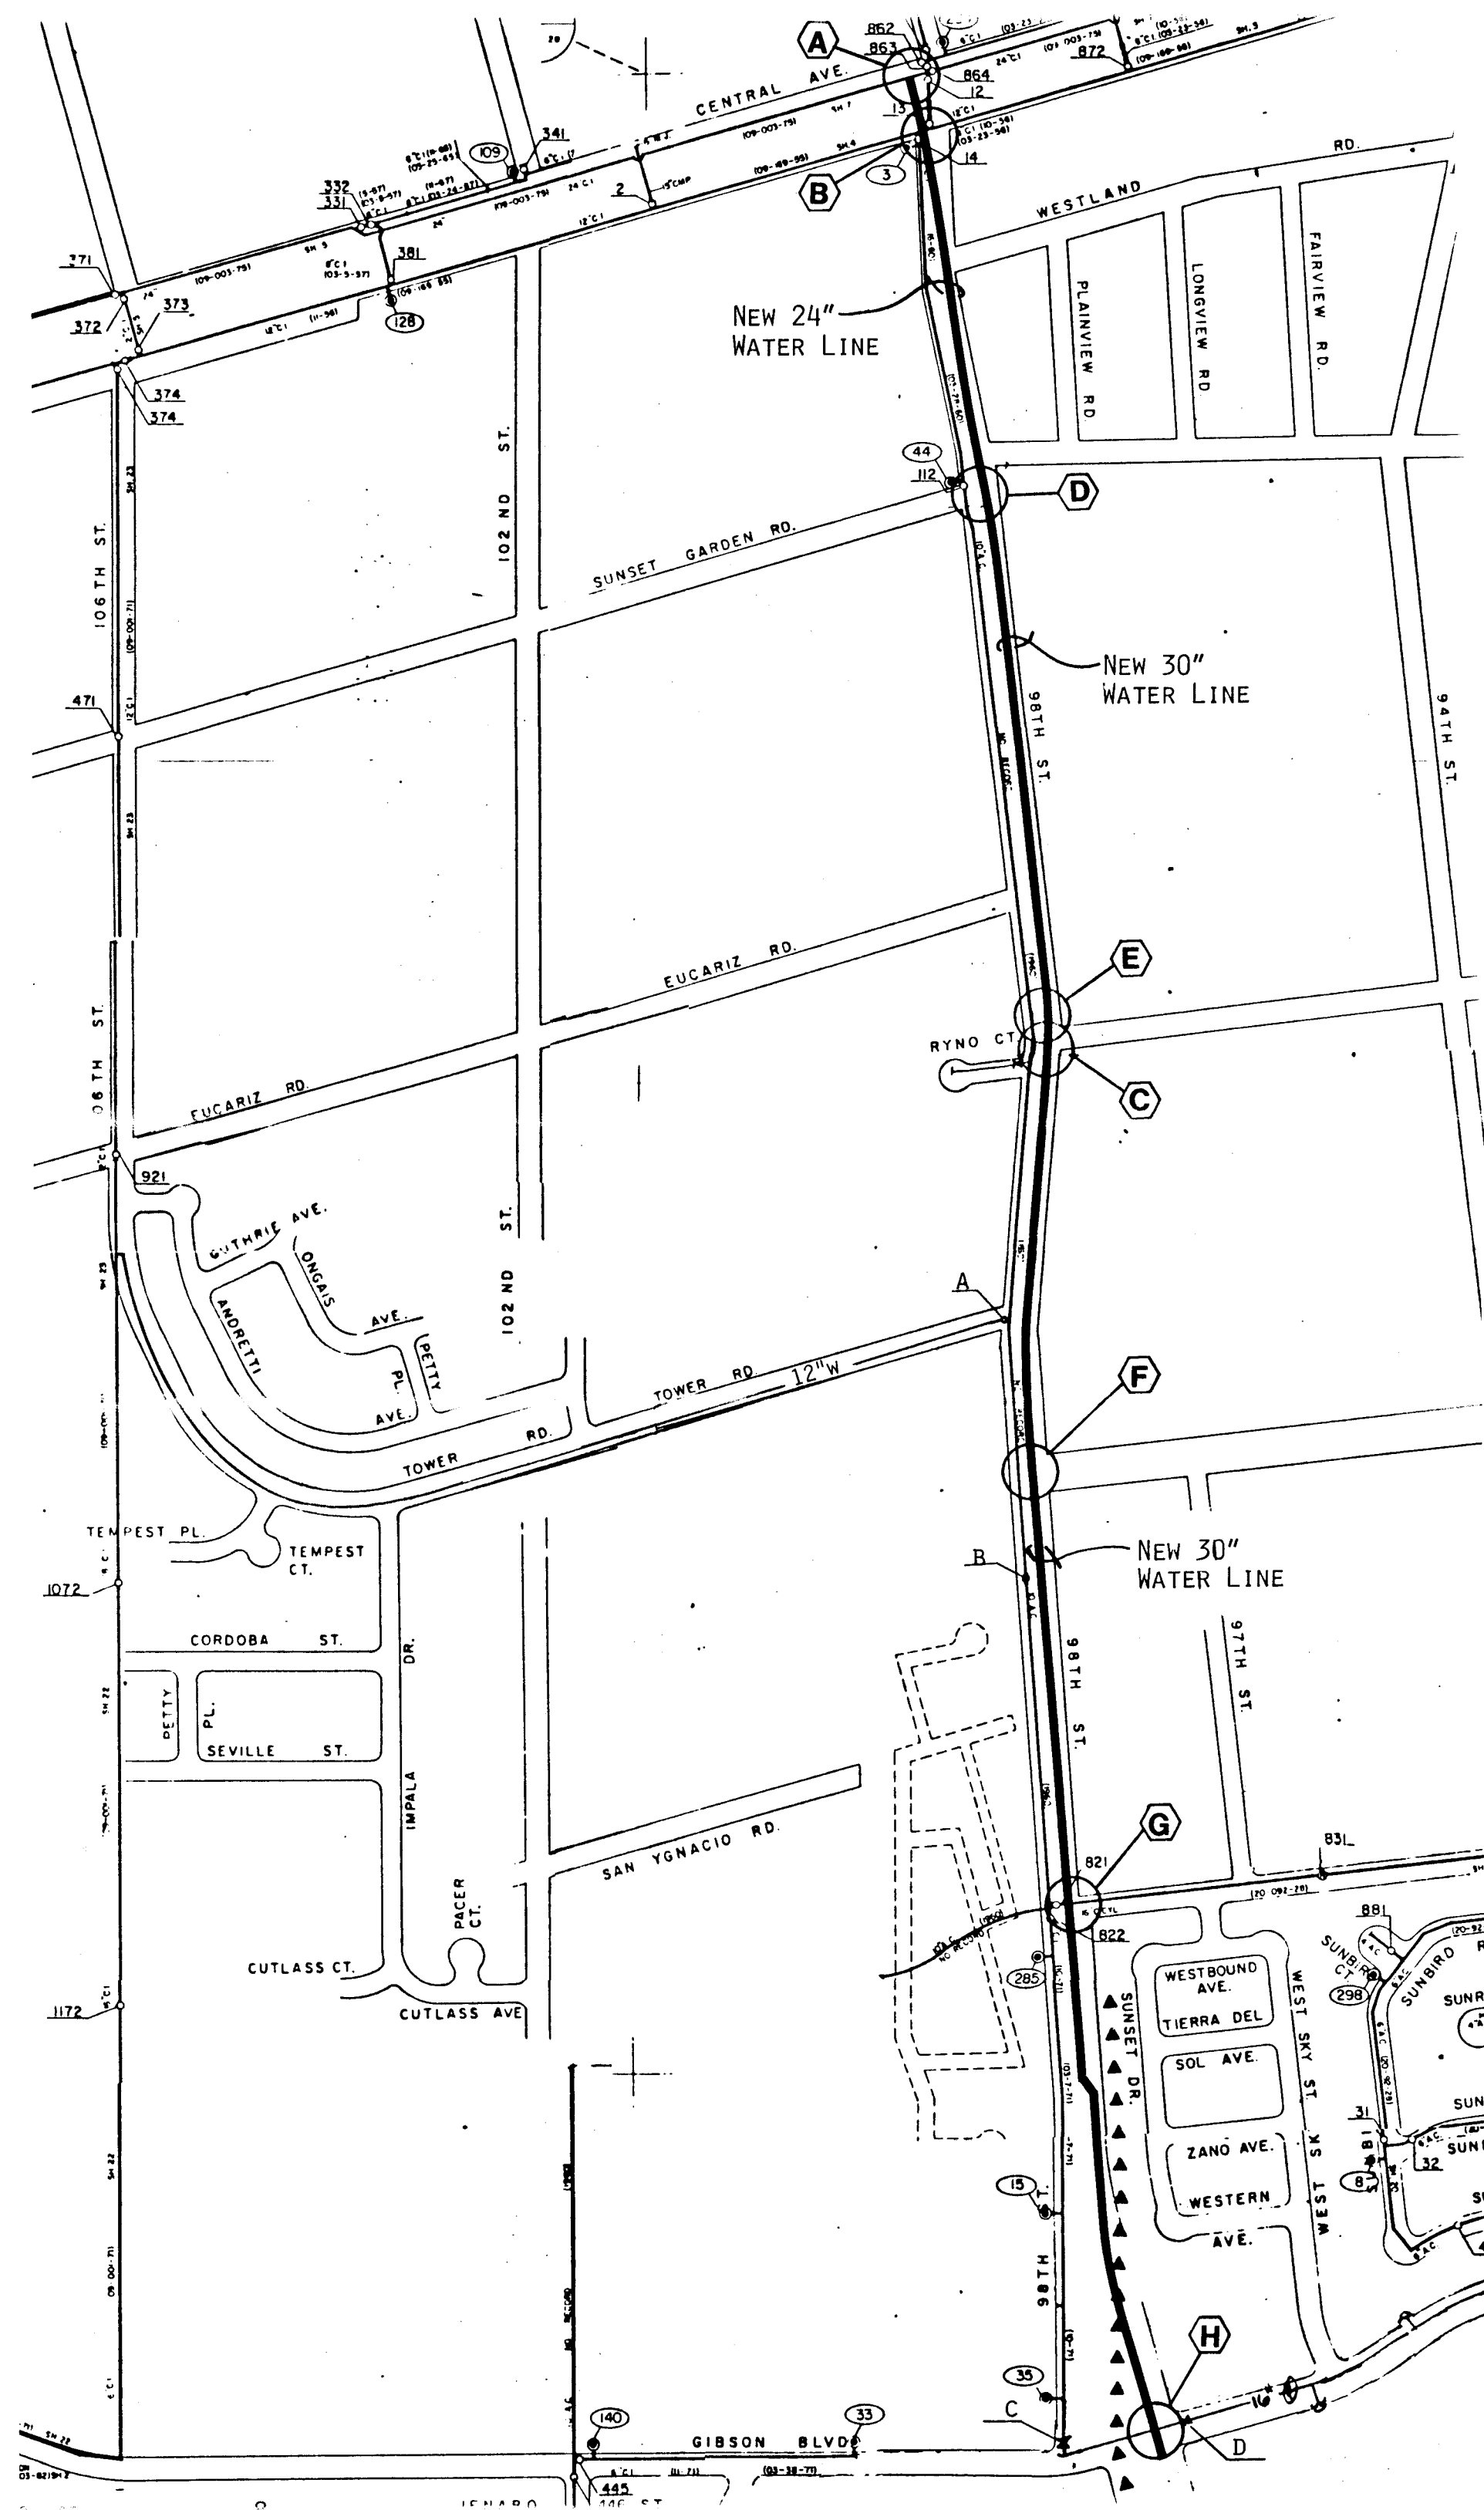

WATER VALVE SHUT-OFF PLAN
SCALE: 1" = 400'

KEYED LOCATION

A

CONNECTION TO EXISTING 24" LINE SHALL BE MADE WITH VALVES NO. 371, 372, 863, 864, AND 12 CLOSED. SHUT DOWN LIMITED TO EIGHT (8) HOURS.

B

PRESSURE CONNECTION TO EXISTING 12" LINE SHALL BE MADE WITHOUT CLOSING ANY VALVES.

C

INSERTION OF 8" VALVE IN EXISTING LINE (AT STATION 27+90±) SHALL BE MADE BY CLOSING VALVES NO. 112, A, AND B. SHUT DOWN LIMITED TO EIGHT (8) HOURS.

D

CONNECTION TO EXISTING 8" LINE SHALL BE MADE BY CLOSING VALVE NO. 112 AND THE NEW VALVE INSTALLED IN PART C ABOVE. THERE ARE NO SERVICES IN THIS REACH, THEREFORE SHUT DOWN TIME WILL BE LIMITED TO THIRTY-SIX (36) HOURS.

E

CONNECTION TO EXISTING 8" LINE SHALL BE MADE BY THE SAME PROCEDURE DESCRIBED IN PART D ABOVE. SHUT DOWN TIME LIMITED TO THIRTY-SIX (36) HOURS.

F

CONNECTION TO EXISTING 8" LINE SHALL BE MADE WITH VALVES NO. A, B, AND THE NEW VALVE, INSTALLED IN PART C ABOVE, CLOSED. SHUT DOWN TIME LIMITED TO EIGHT (8) HOURS.

G

CONNECTION TO EXISTING 16" LINE SHALL BE MADE WITH VALVES NO. 821 AND 831 CLOSED. THE EXISTING 16" LINE WILL NEED TO BE LOWERED PRIOR TO MAKING THIS CONNECTION, THEREFORE SHUT DOWN TIME LIMITED TO SIXTY (60) HOURS.

H

CONNECTION TO EXISTING 16" LINE SHALL BE MADE WITH VALVES NO. C AND D CLOSED. SHUT DOWN TIME LIMITED TO THIRTY-SIX (36) HOURS.

PROCEDURE

AS BUILT INFORMATION

CONTRACTOR	CCM	DATE	6/1/88
WORK	SDG	DATE	6/1/88
STARTED BY	SDG	DATE	6/1/88
INSPECTED BY	SDG	DATE	6/1/88
FIELD	SDG	DATE	6/1/88
DRAWN BY	SDG	DATE	6/1/88
CHECKED BY	SDG	DATE	6/1/88
RECORDED BY	SDG	DATE	6/1/88

BENCH MARKS

SURVEY INFORMATION

NO.	BY	DATE

ENGINEER'S SEAL



REVISIONS

NO.	DATE	REMARKS	BY

26 33770389

APPROVED:

[Signature]
WATER OPERATIONS



3-21-88
DATE

CITY OF ALBUQUERQUE
MUNICIPAL DEVELOPMENT DEPARTMENT
ENGINEERING DIVISION

TITLE: 98th STREET WATERLINE
WATER VALVE
SHUT OFF PLAN

APPROVALS	ENGINEER	DATE	APPROVALS	ENGINEER	DATE
City Engineer	<i>[Signature]</i>	2/10/88	Liquid Waste	<i>[Signature]</i>	3/17/88
A.C.E. Design	<i>[Signature]</i>	2/24/88	Traffic	<i>[Signature]</i>	3/20/88
A.C. E. Hydrology	<i>[Signature]</i>	2/24/88	Water	<i>[Signature]</i>	3/17/88

DRAWING NO. 3377 MAP NO. L-9, M-9 SHEET 3 OF 11

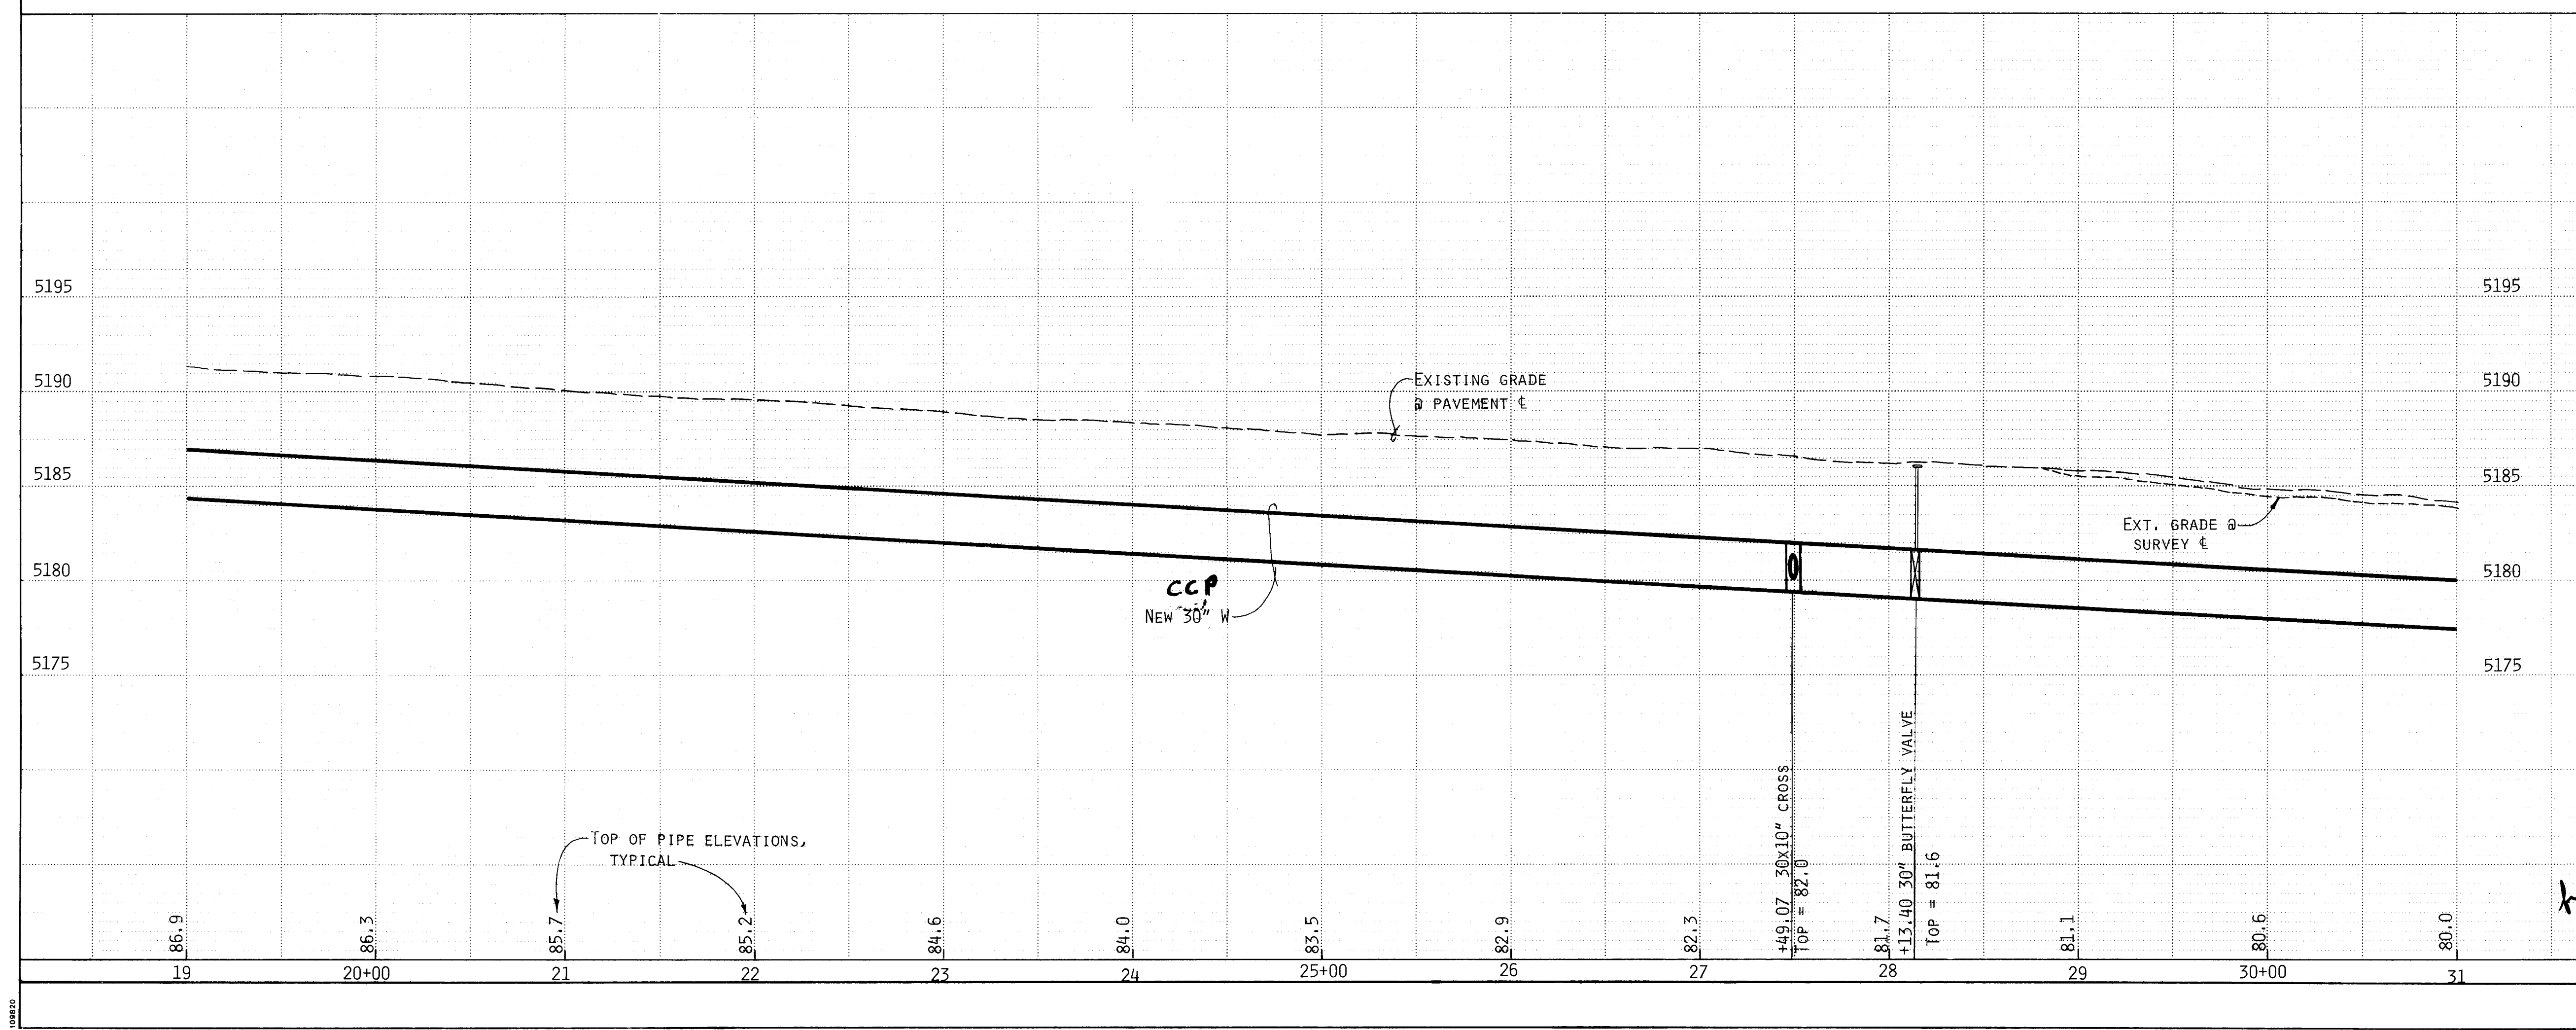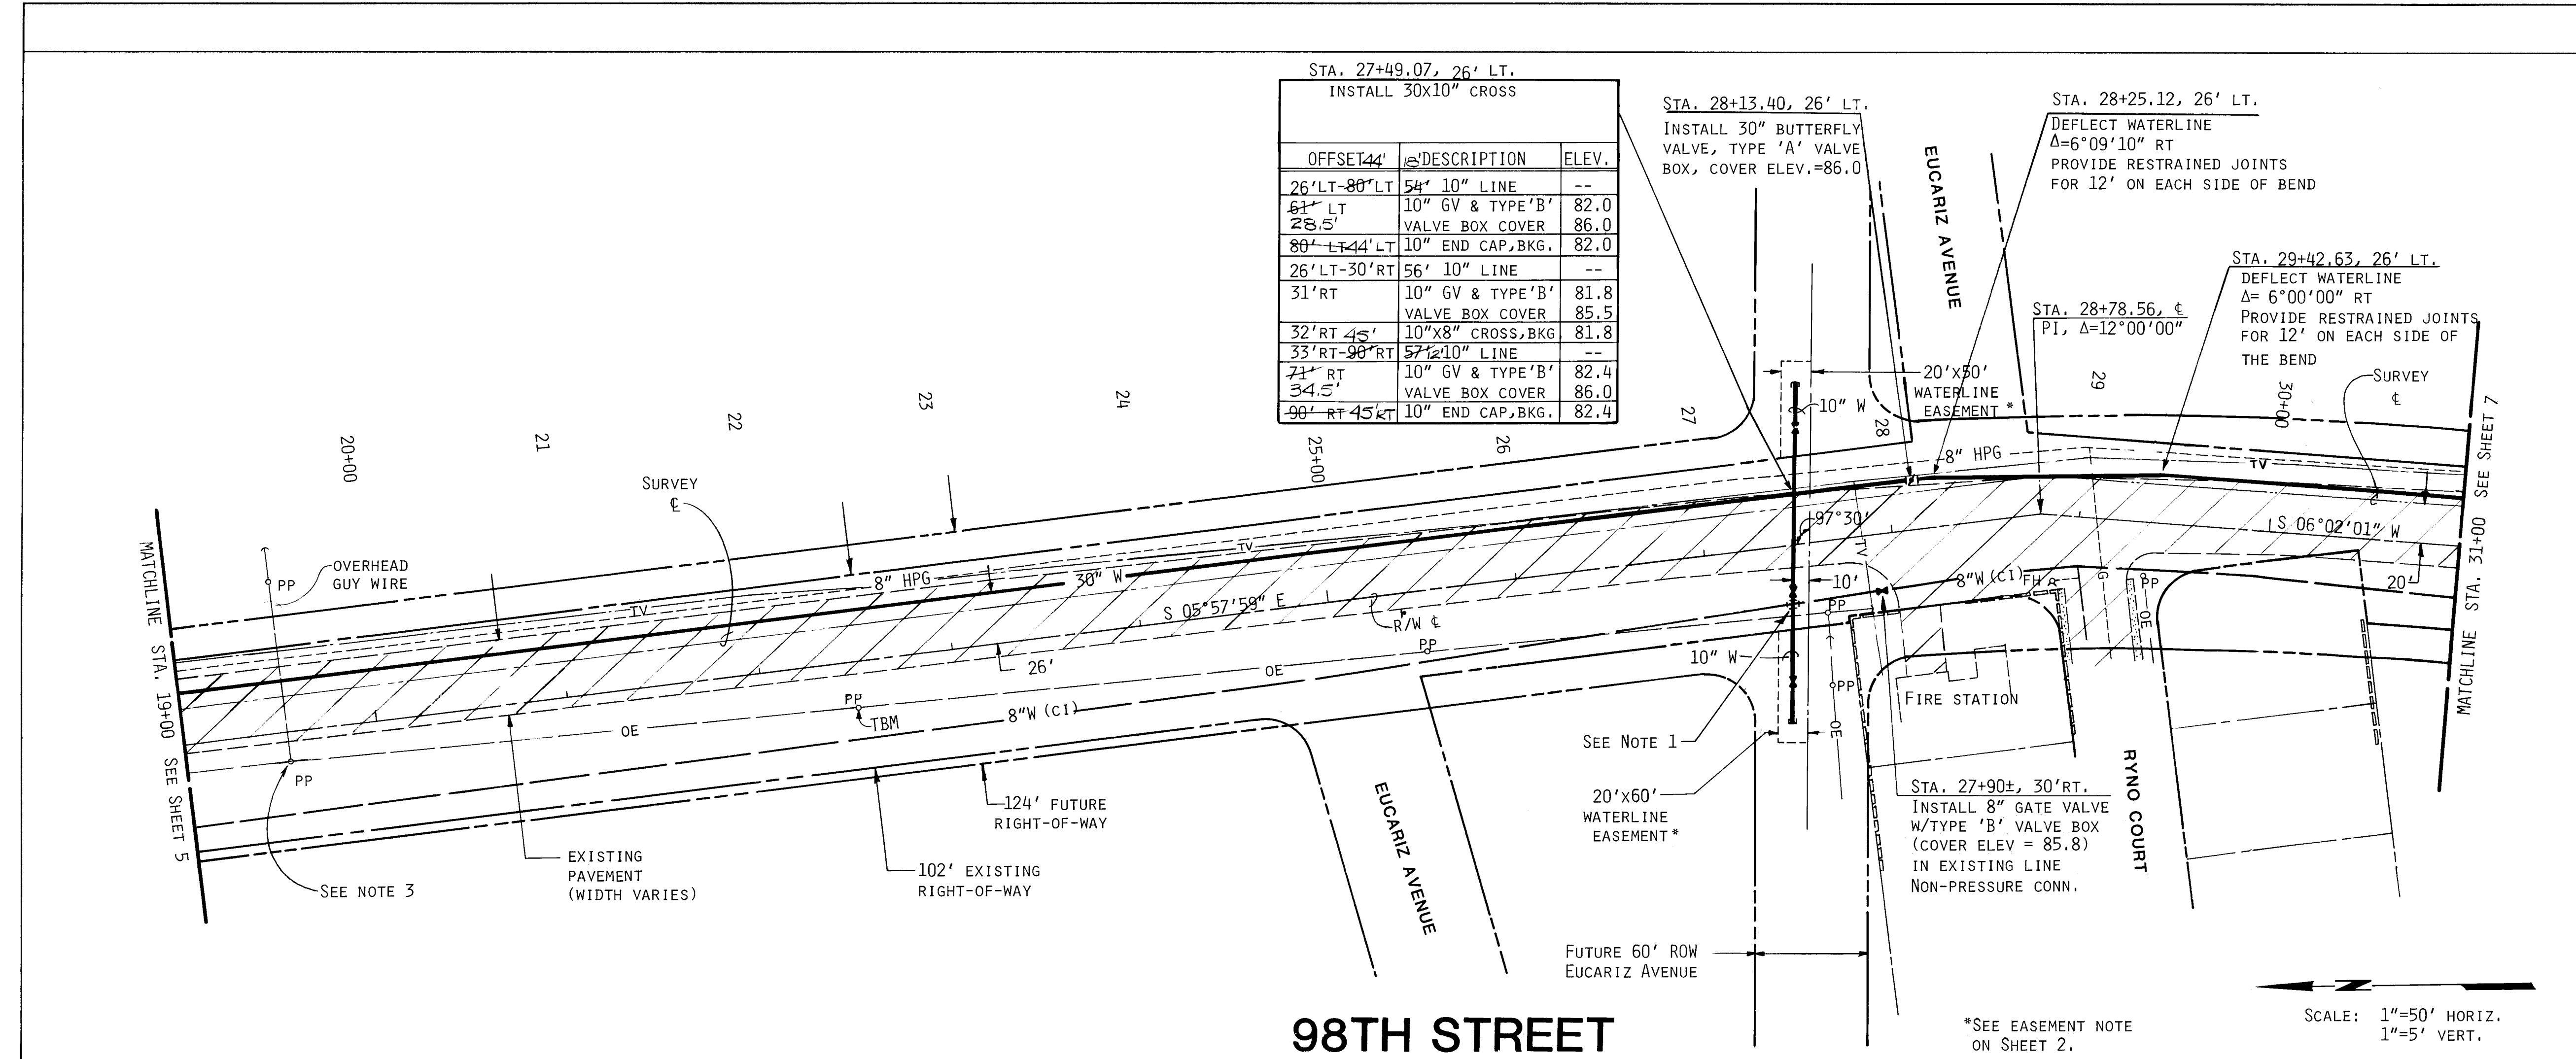

CONSTRUCTION NOTES

- THE EXISTING 8" WATER LINE SHALL BE REMOVED AND RE-INSTALLED AS REQUIRED TO INSTALL THE CROSS AT THE DESIGN GRADE.
- ELEVATIONS LISTED IN NOTE TABLE REFER EITHER TO TOP OF PIPE OR VALVE BOX COVER ELEVATIONS.
- CONTRACTOR SHALL INSTALL AND MAINTAIN PROTECTIVE TRAFFIC DEVICES AROUND EXISTING POWER POLE IF TRAFFIC IS SHIFTED WEST OFF OF THE EXISTING ASPHALT PAVEMENT.

AS BUILT INFORMATION

CONTRACTOR	CCM	WORK BY	DATE	INSPECTOR'S	DATE	FIELD	DATE	CONTRACTOR	DATE	RECORDED BY	DATE
SPG		DATE	10/87	DATE	10/87	DATE	10/87	DATE	10/87	DATE	10/87

BENCH MARKS

SURVEY INFORMATION

FIELD NOTES

NO. 1 BY M.P.

DATE 10/87

IN A POWER POLE ON THE WEST SIDE OF 98TH STREET SW LOCATED 0.2 MILES SOUTH OF CENTRAL AVENUE

ELEVATION: 5195.19

ENGINEER'S SEAL

12-23-91



REVISIONS

NO.	DATE	REMARKS
1	3/30/88	DESIGN
2	3/30/88	DESIGN
3	3/30/88	DESIGN
4	3/30/88	DESIGN
5	3/30/88	DESIGN
6	3/30/88	DESIGN
7	3/30/88	DESIGN
8	3/30/88	DESIGN
9	3/30/88	DESIGN
10	3/30/88	DESIGN
11	3/30/88	DESIGN
12	3/30/88	DESIGN

DESIGNED BY SWM DATE 12/87

DRAWN BY NAF DATE 12/87

CHECKED BY FCA DATE 12/87

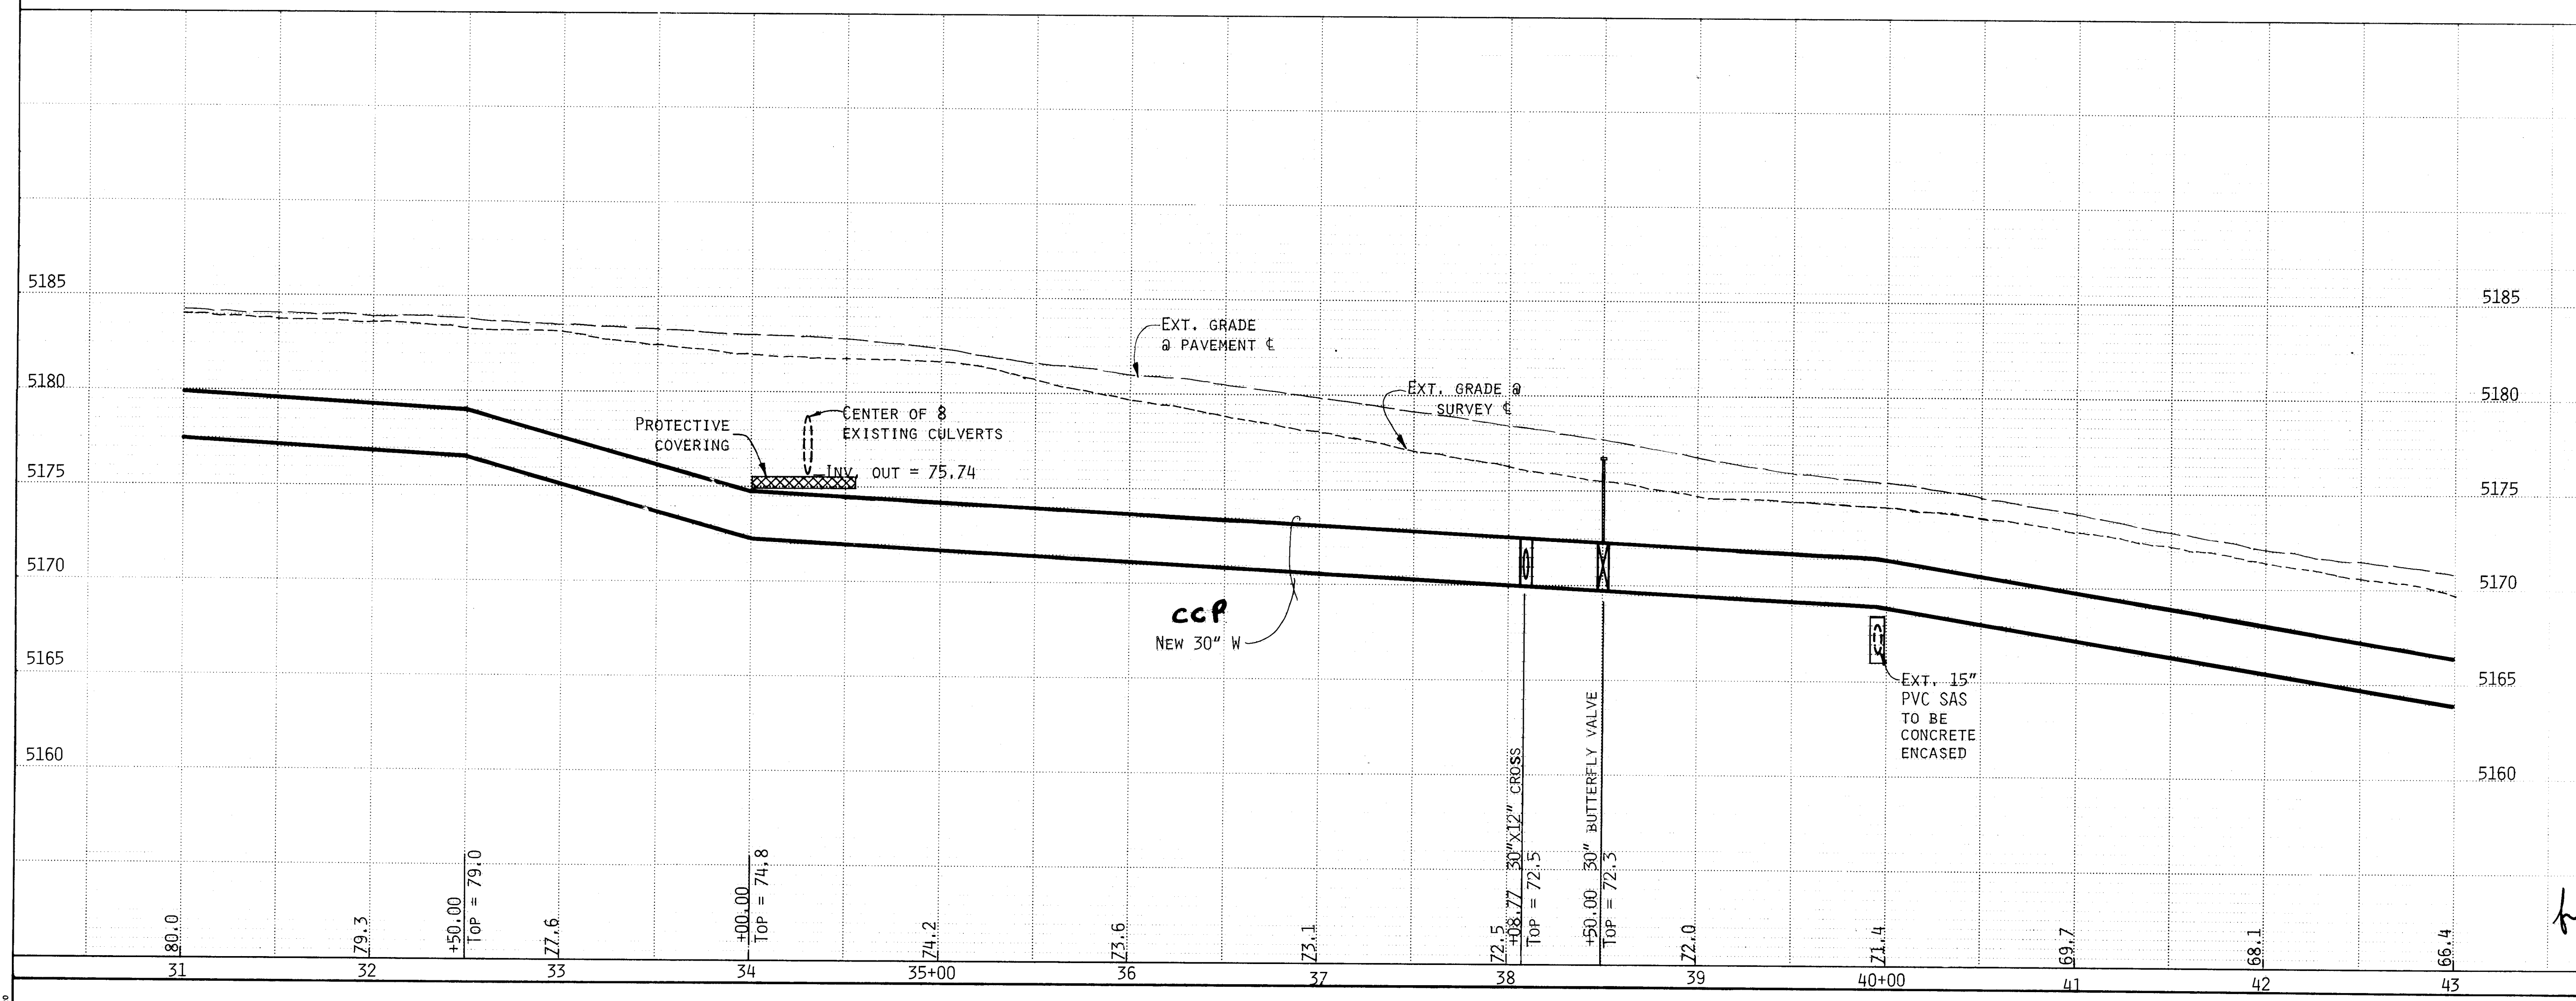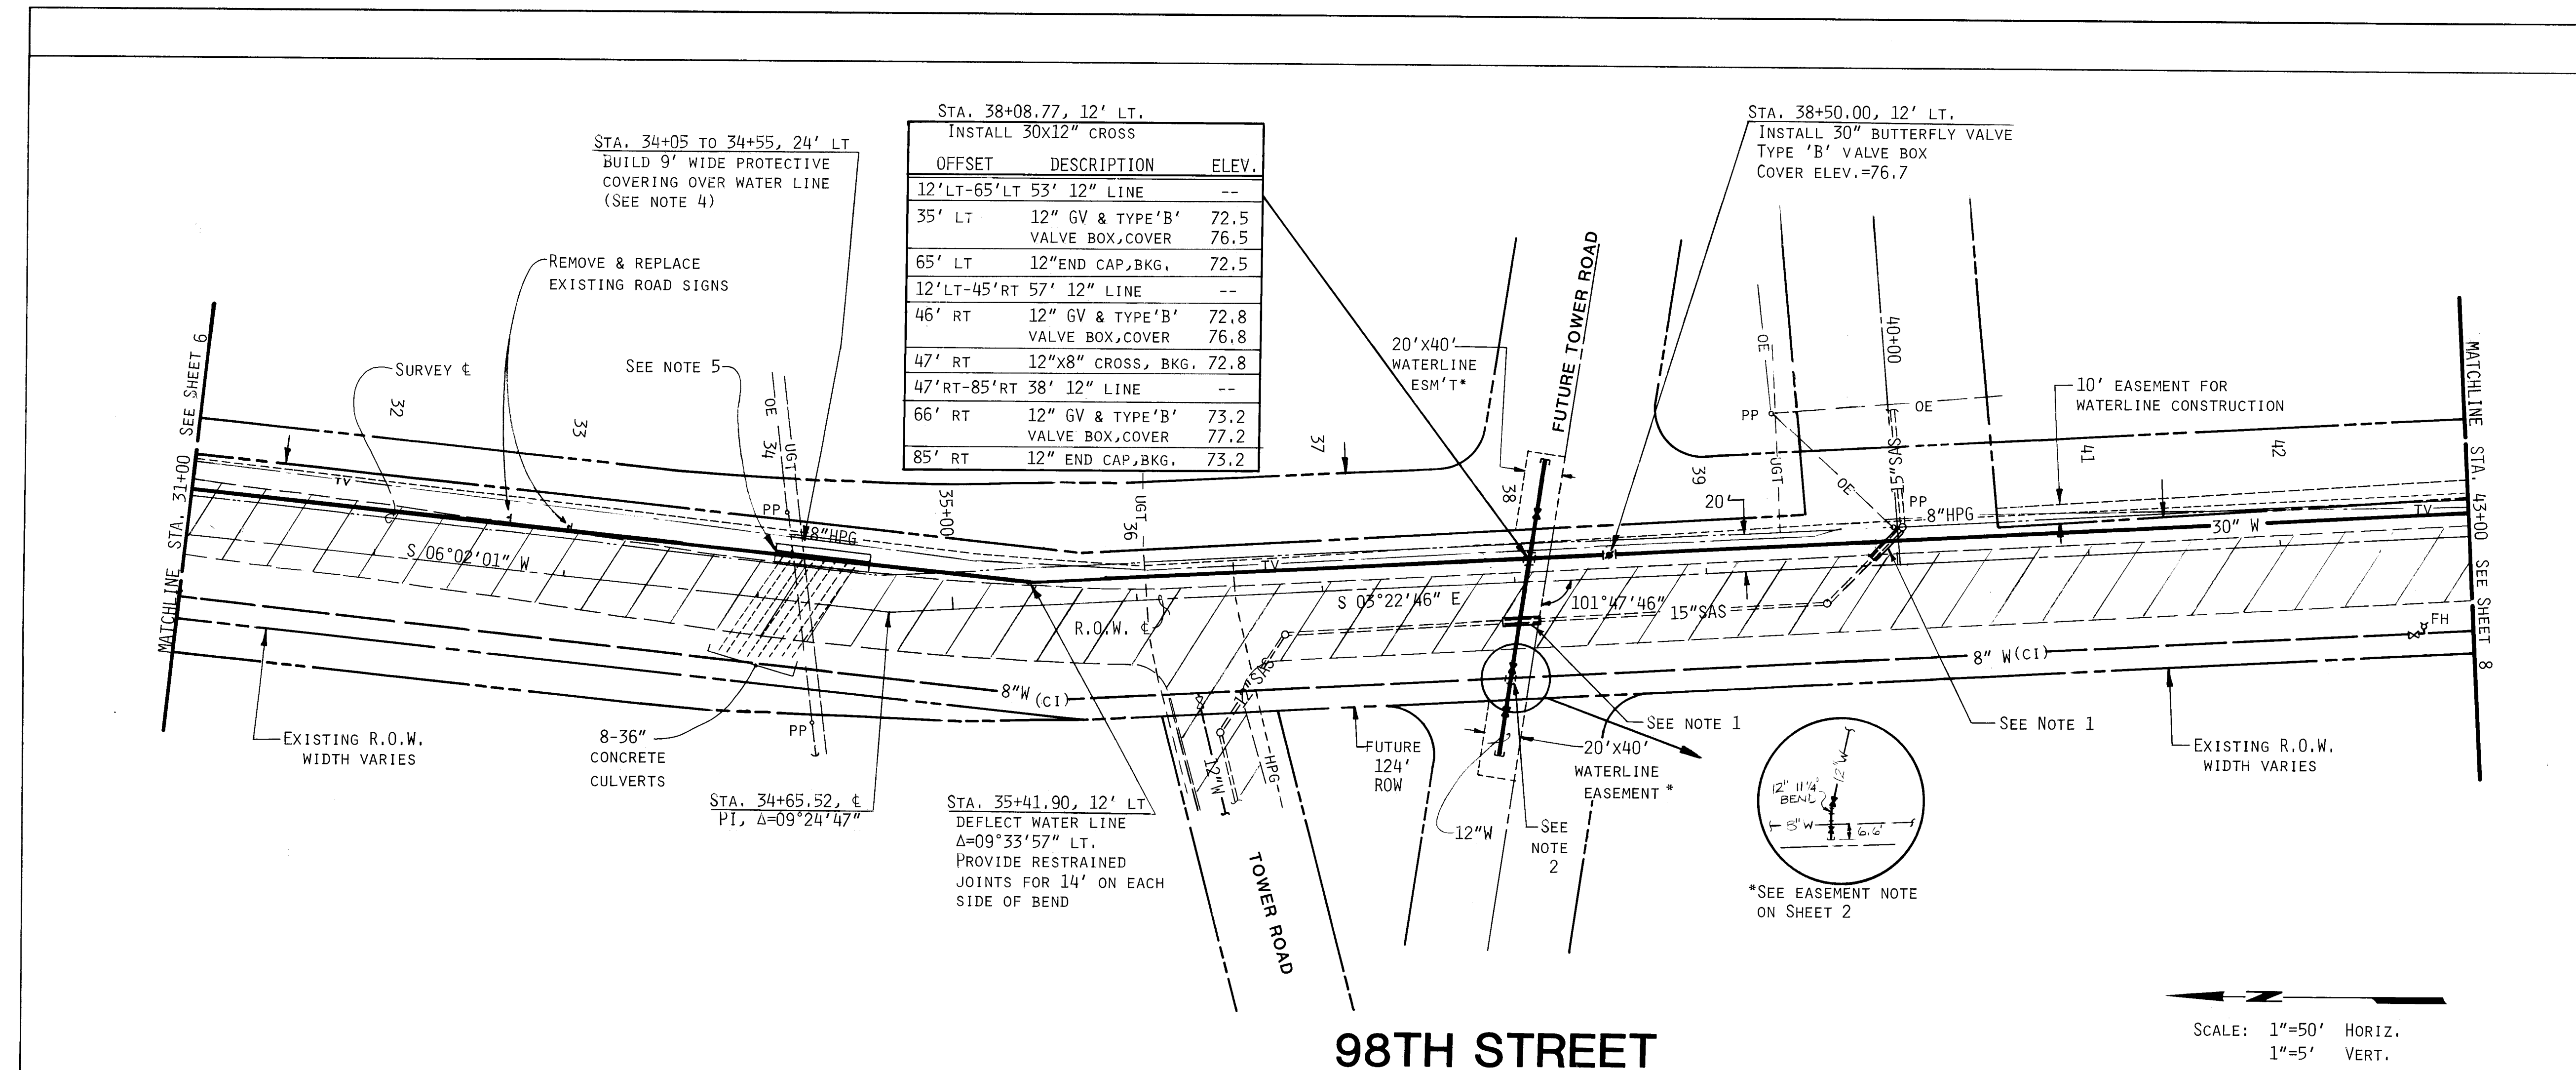

CONSTRUCTION NOTES

- THE EXISTING 15" PVC SANITARY SEWER LINE SHALL BE CONCRETE ENCASED FOR 10' ON EITHER SIDE OF THE WATERLINE
- THE EXISTING 8" WATER LINE SHALL BE REMOVED AND RE-INSTALLED AS REQUIRED TO INSTALL THE CROSS AT THE DESIGN GRADE.
- ELEVATIONS LISTED IN NOTE TABLE ARE EITHER TOP OF PIPE OR VALVE BOX COVER ELEVATIONS.
- PROTECTIVE COVERING SHALL BE EITHER FIFTY FOOT LONG GABION MATTRESS: NINE (9) FEET WIDE AND NINE (9) INCHES THICK, CENTERED OVER WATER LINE (LIGHT DUTY ROCK) OR FIFTY FEET OF NON-STRUCTURAL CONCRETE (2500 PSI MIN) WITH THE ABOVE DIMENSIONS, ROUGH FINISHED WITH A 1" CROWN
- EXISTING UNDERGROUND TELEPHONE IS SHOWN APPROXIMATELY. THE CONTRACTOR SHALL HAVE A UTILITY REPRESENTATIVE STANDING BY BEFORE TRENCHING IN THE AREA BEGINS.

LEGEND

- EXT. R.O.W. LINE
- FUTURE R.O.W. LINE
- FUTURE CENTERLINE
- 8"HPG--- EXT. GAS MAIN
- PP---OE--- EXT. POWER POLE W/OH ELEC.
- UGT --- EXT. BURIED TELE.
- ==15"SAS== EXT. SANITARY SEWER
- 8"W --- EXT. WATER LINE
- 30"W --- PROPOSED WATER LINE

NO.	DATE	REVISIONS	BY
1	2/6	3	3
2	3	3	3
3	3	3	3
4	3	3	3
5	3	3	3
6	3	3	3
7	3	3	3
8	3	3	3
9	3	3	3
10	3	3	3
11	3	3	3
12	3	3	3



CITY OF ALBUQUERQUE

MUNICIPAL DEVELOPMENT DEPARTMENT
ENGINEERING DIVISION

TITLE: 98th STREET WATERLINE
PLAN & PROFILE
STA. 31+00 TO STA. 43+00

APPROVALS	ENGINEER	DATE	APPROVALS	ENGINEER	DATE
City Engineer	[Signature]	3/20/88	Liquid Waste	[Signature]	3/17/88
A C E - Design	[Signature]	3/20/88	Traffic	[Signature]	3/30/88
A C E - Hydrology	[Signature]	3/24/88	Water	[Signature]	3/17/88

DRAWING NO. 3377 MAP NO. L-9 SHEET 7 OF 11

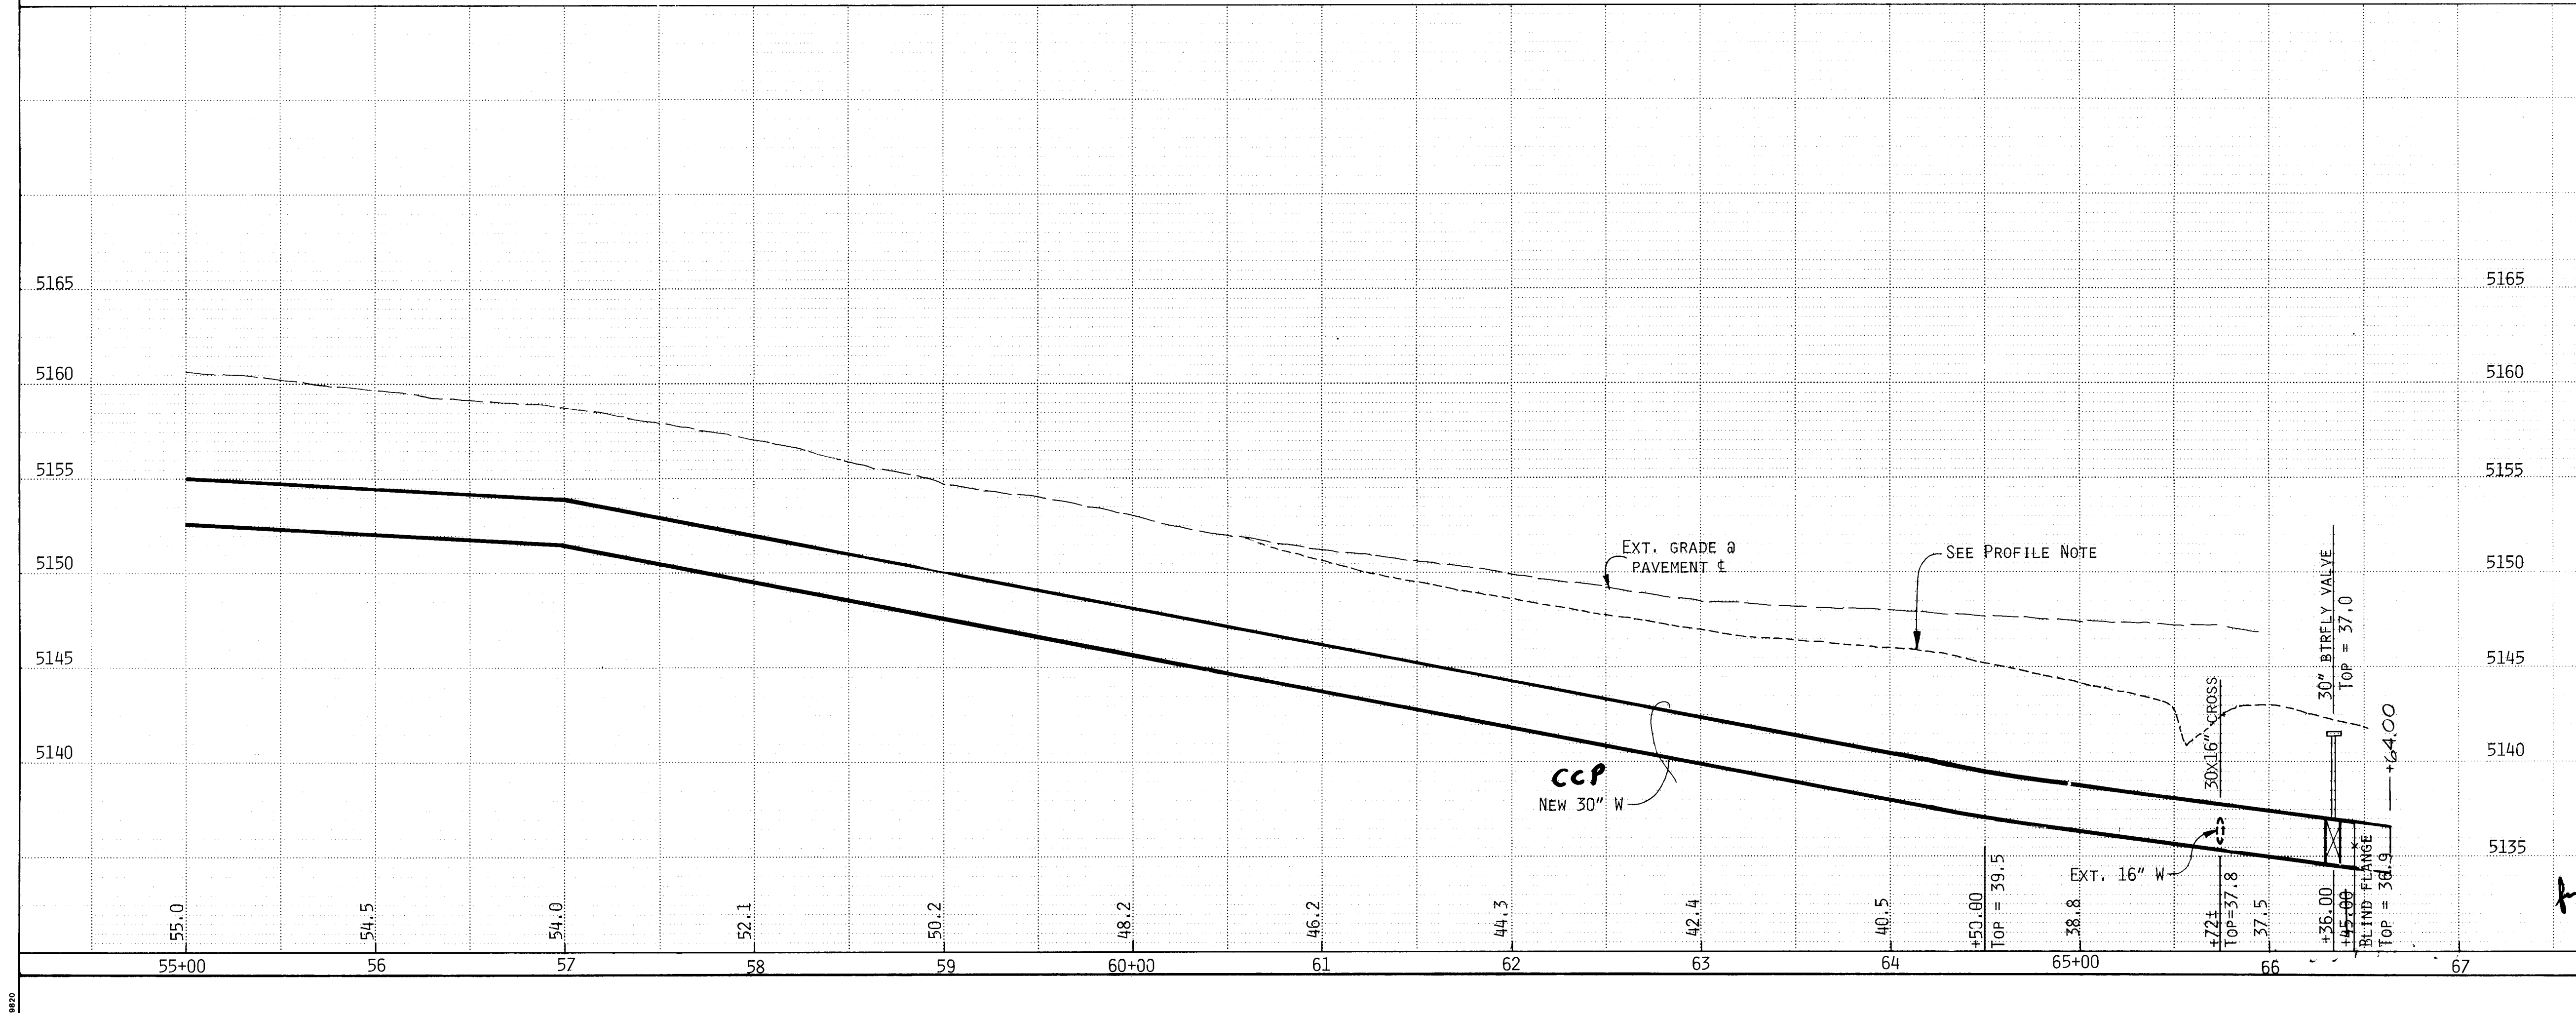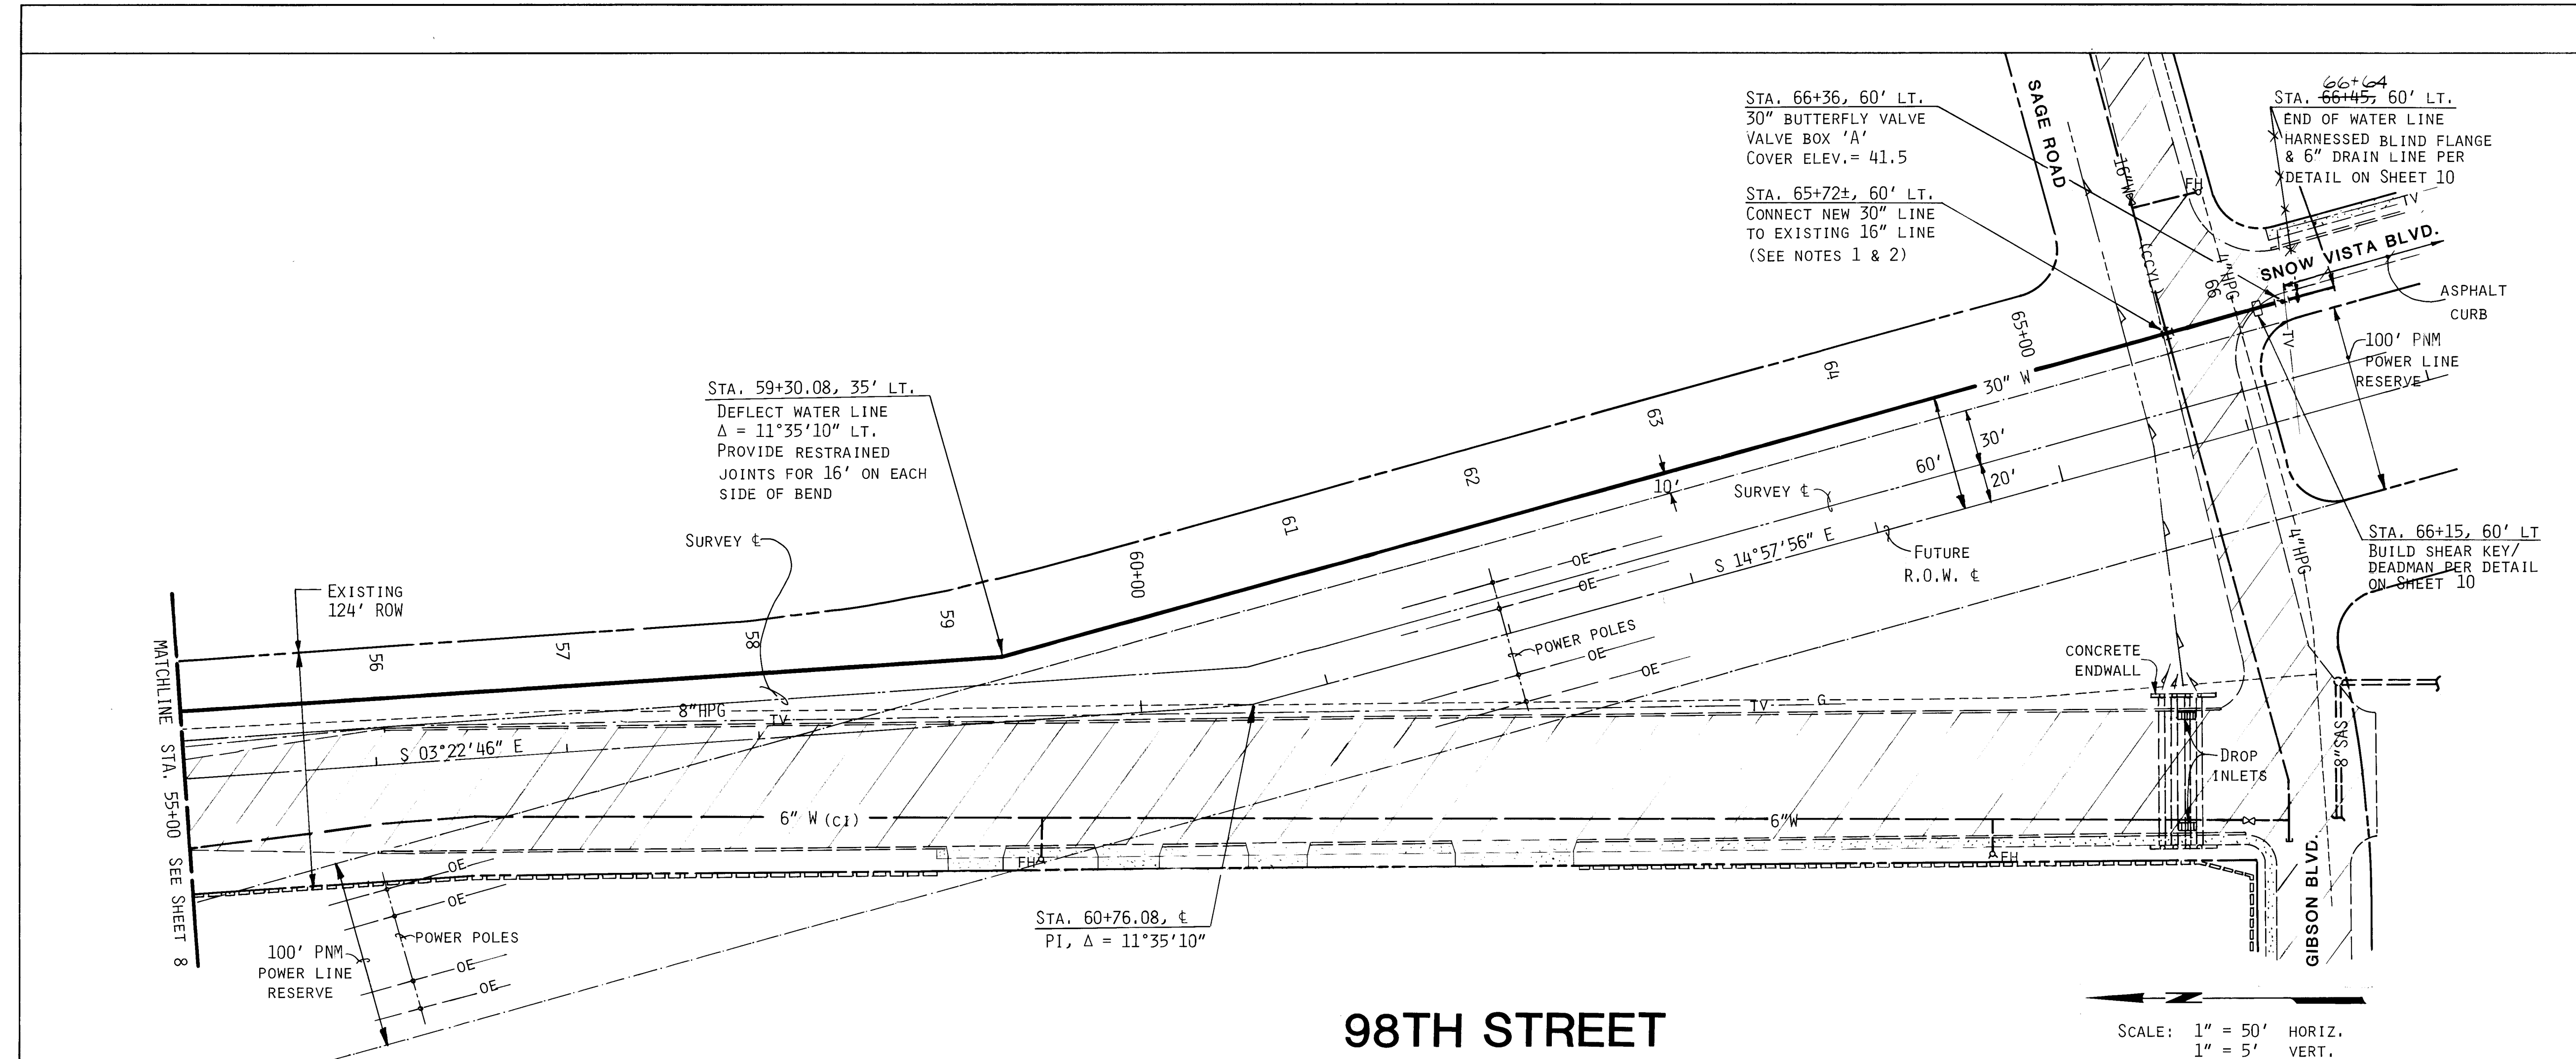

CONSTRUCTION NOTES

- THE CONTRACTOR SHALL UNCOVER THE EXISTING 16" WATER LINE, PRIOR TO ANY EXCAVATION, TO VERIFY THE HORIZONTAL & VERTICAL ALIGNMENT. THE 16" LINE SHALL BE REMOVED & RE-INSTALLED AS REQUIRED TO INSTALL THE 30" BY 16" CROSS AT THE DESIGN GRADE SHOWN.
- PROVIDE RESTRAINED JOINTS FROM STA. 65+42 TO STA. 66+45.

PROFILE NOTE

SECOND PROFILE LINE SHOWN IS EXISTING GROUND ALONG THE EASTERLY LINE OF THE 100' PNM POWER LINE RESERVE.

LEGEND

- EXT. R.O.W. LINE
- EXT. CONCRETE CURB
- EXT. DRAINAGE DITCH
- 16" W --- EXT. WATERLINE
- == 8" SAS == EXT. SANITARY SEWER
- 30" W --- PROPOSED WATER LINE
- 8" HPG --- EXT. GAS MAIN
- TV --- EXT. TELEVISION CABLE

REVISIONS	
NO.	DATE
1	12/87
2	12/87
3	12/87
4	12/87
5	12/87
6	12/87
7	12/87
8	12/87
9	12/87
10	12/87
11	12/87
12	12/87


DESIGNED BY		DRAWN BY		CHECKED BY	
DATE	BY	DATE	BY	DATE	BY
12/87	SM	12/87	NAF	12/87	FCA

CITY OF ALBUQUERQUE
MUNICIPAL DEVELOPMENT DEPARTMENT
ENGINEERING DIVISION

TITLE: 98th STREET WATERLINE
PLAN & PROFILE
STA. 55+00 TO STA. 66+45

APPROVALS	ENGINEER	DATE	APPROVALS	ENGINEER	DATE
City Engineer	[Signature]	3/24/88	Liquid Waste	[Signature]	3/17/88
A C E - Design	[Signature]		Traffic	[Signature]	3/20/88
A C E - Hydrology	[Signature]	2/24/88	Water	[Signature]	3/17/88

DRAWING NO. 3377 MAP NO. M-9 SHEET 9 OF 11

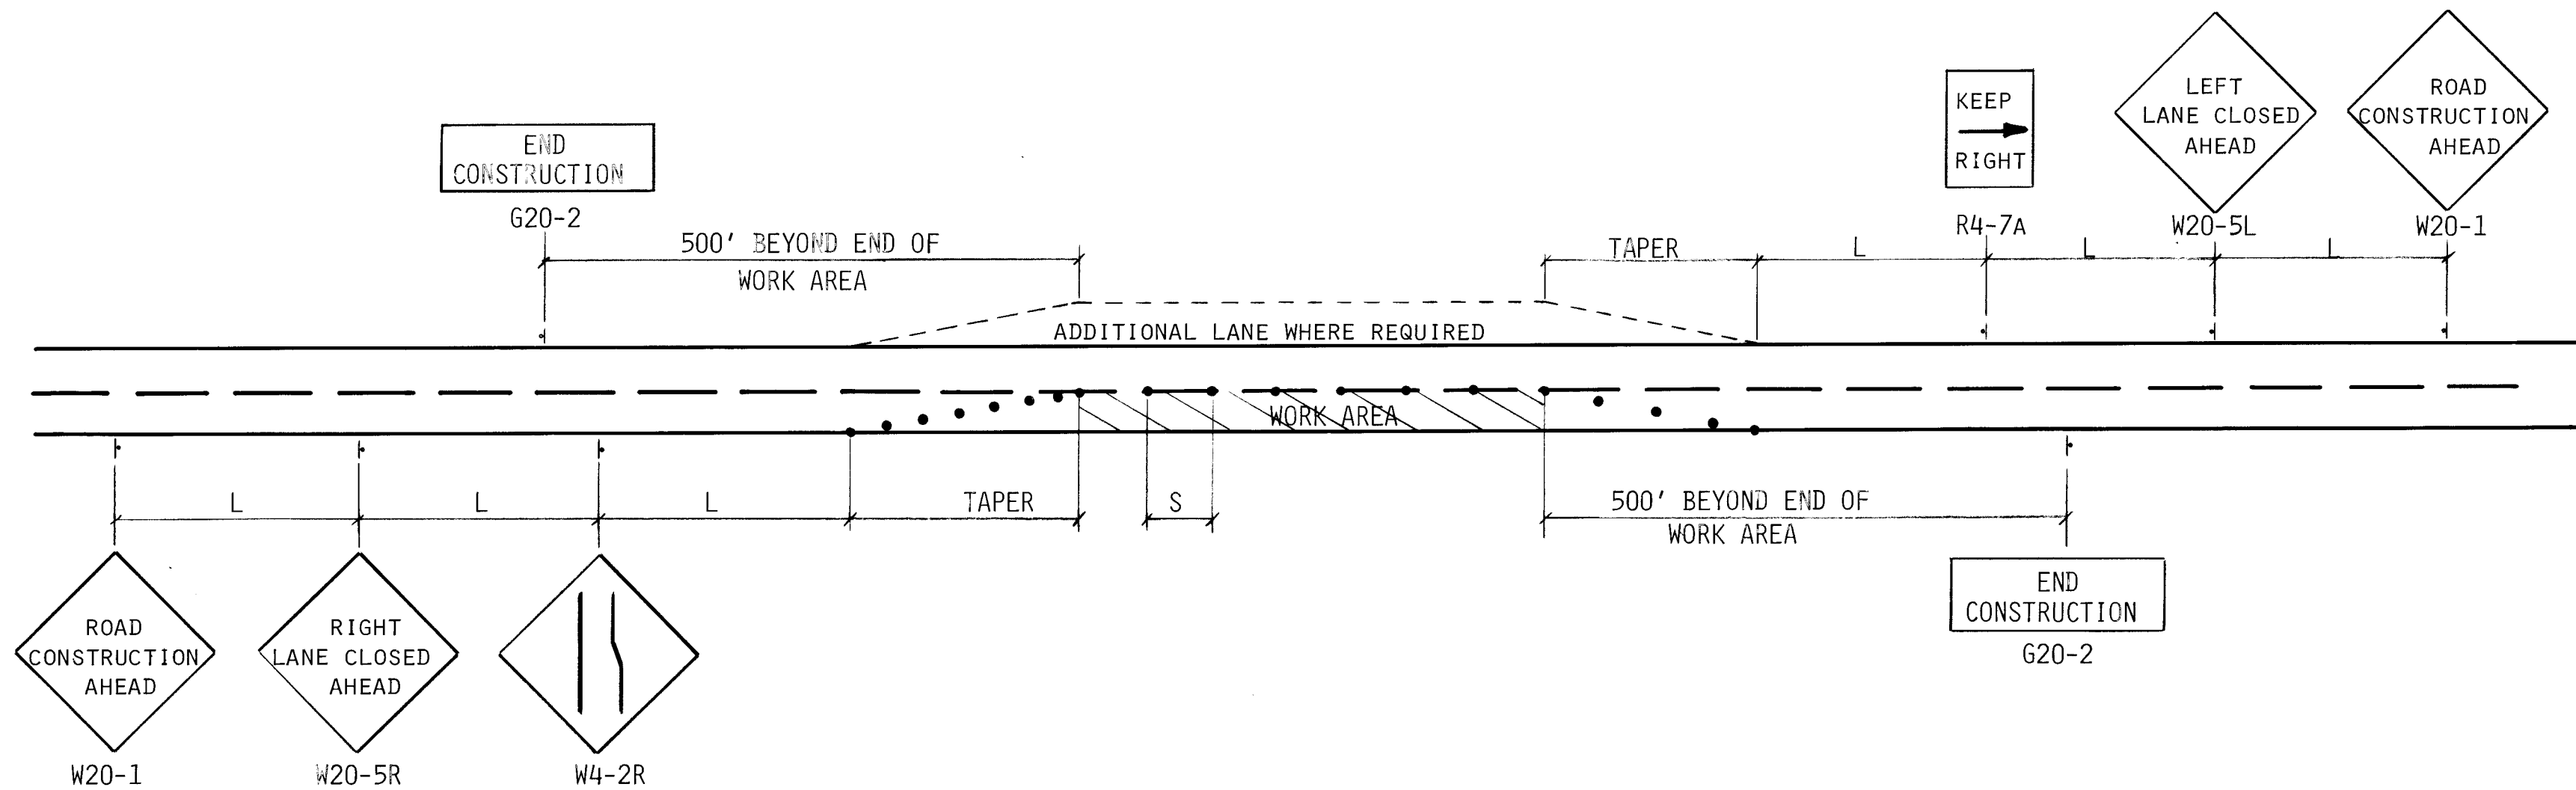

Typical Lane Closure /Detour
No SCALE

- LEGEND**
- WORK AREA
 - BARRICADE - TYPE I, II, OR BARREL
 - WARNING SIGN
 - DISTANCE BETWEEN SIGNS - A DISTANCE (FEET) EQUAL TO 10 TIMES THE SPEED LIMIT
 - SPACING BETWEEN BARRICADES - A DISTANCE (FEET) EQUAL TO THE SPEED LIMIT
 - SEE CHART FOR LENGTH

SPEED LIMIT MPH	TAPER LENGTH (FEET)			MAXIMUM DISTANCE BETWEEN DEVICES (FEET)	MINIMUM NUMBER OF DEVICES REQUIRED
	10' LANE	11' LANE	12' LANE		
25	104	115	125	25	6
30	150	165	185	30	7
35	204	225	245	35	8
40	267	293	320	40	9
45	450	495	540	45	13

Traffic Control Notes

1. THE CONTRACTOR SHALL COMPLY WITH SECTION 19 OF THE GENERAL CONDITIONS OF THE CITY OF ALBUQUERQUE STANDARD SPECIFICATIONS FOR CONSTRUCTION, 1986.
2. THE CONTRACTOR SHALL COMPLY WITH SECTION SP - 3 OF THE PUBLIC WORKS CONTRACT REGARDING CONSTRUCTION NOTICE PUBLICATIONS.
3. THE CONTRACTOR SHALL COMPLY WITH ALL NEW MEXICO STATE HIGHWAY DEPARTMENT REGULATIONS WHEN WORKING WITHIN THE RIGHT OF WAY OF CENTRAL AVENUE.
4. THE LENGTH OF OPEN TRENCH SHALL BE LIMITED TO NO MORE THAN FOUR HUNDRED (400) FEET. THE CONTRACTOR MAY NOT PROCEED WITH EXCAVATION UNTIL PREVIOUS EXCAVATION IS READY FOR TRAFFIC (EVEN WHERE ASPHALTIC PAVEMENT IS REQUIRED).
5. WHEN THE WIDTH OF THE TRAVELED WAY OF 98TH STREET IS REDUCED TO LESS THAN TWENTY-FOUR (24) FEET, THE CONTRACTOR SHALL GRADE, COMPACT, AND WATER TWICE DAILY AN ADDITIONAL LANE OFF 98TH STREET.
6. THE CONTRACTOR SHALL INSURE THAT THE FIRE STATION, LOCATED AT RYNO COURT AND 98TH STREET, HAS EASY ACCESS TO ROADWAY AT ALL TIMES.
7. ONE LANE OF TRAFFIC IN EACH DIRECTION SHALL BE MAINTAINED AT ALL TIMES ON 98TH STREET AND ON CENTRAL AVENUE.
8. AT THE INTERSECTION OF SAGE ROAD AND 98TH STREET, THE CONTRACTOR SHALL INSTALL PIPE BY QUADRANT SECTIONS. THE CONTRACTOR SHALL MAINTAIN ONE LANE OF TRAFFIC IN EACH DIRECTION FOR THE ENTIRE INTERSECTION.
9. RECOMMENDED SPEED LIMIT IN AREA OF CONSTRUCTION NOT TO EXCEED 25 MPH.

1 2 3 4 5 6 7 8 9 10 11 12
26 33 77 11 89

CITY OF ALBUQUERQUE MUNICIPAL DEVELOPMENT DEPARTMENT ENGINEERING DIVISION				
TITLE: 98th STREET WATERLINE TRAFFIC CONTROL DETAILS & NOTES				
APPROVALS	ENGINEER	DATE	APPROVALS	ENGINEER
City Engineer	<i>[Signature]</i>	5/24/88	Liquid Waste	<i>[Signature]</i>
A.C.E. Design	<i>[Signature]</i>		Traffic	<i>[Signature]</i>
A.C. E.-Hydrology	<i>[Signature]</i>	2/26/88	Water	<i>[Signature]</i>
DRAWING NO. 3377		MAP NO. L-9, M-9		SHEET 11 OF 11