

CONSTRUCTION PLANS AND DETAILS FOR


ARROYO DEL OSO GOLF COURSE

ADDITIONAL NINE HOLES

CITY OF ALBUQUERQUE, NM

CONSULTANTS

JOHANNAN HUSTON, INC. ALBUQUERQUE
IRRIGATION ENGINEERING-BOISE

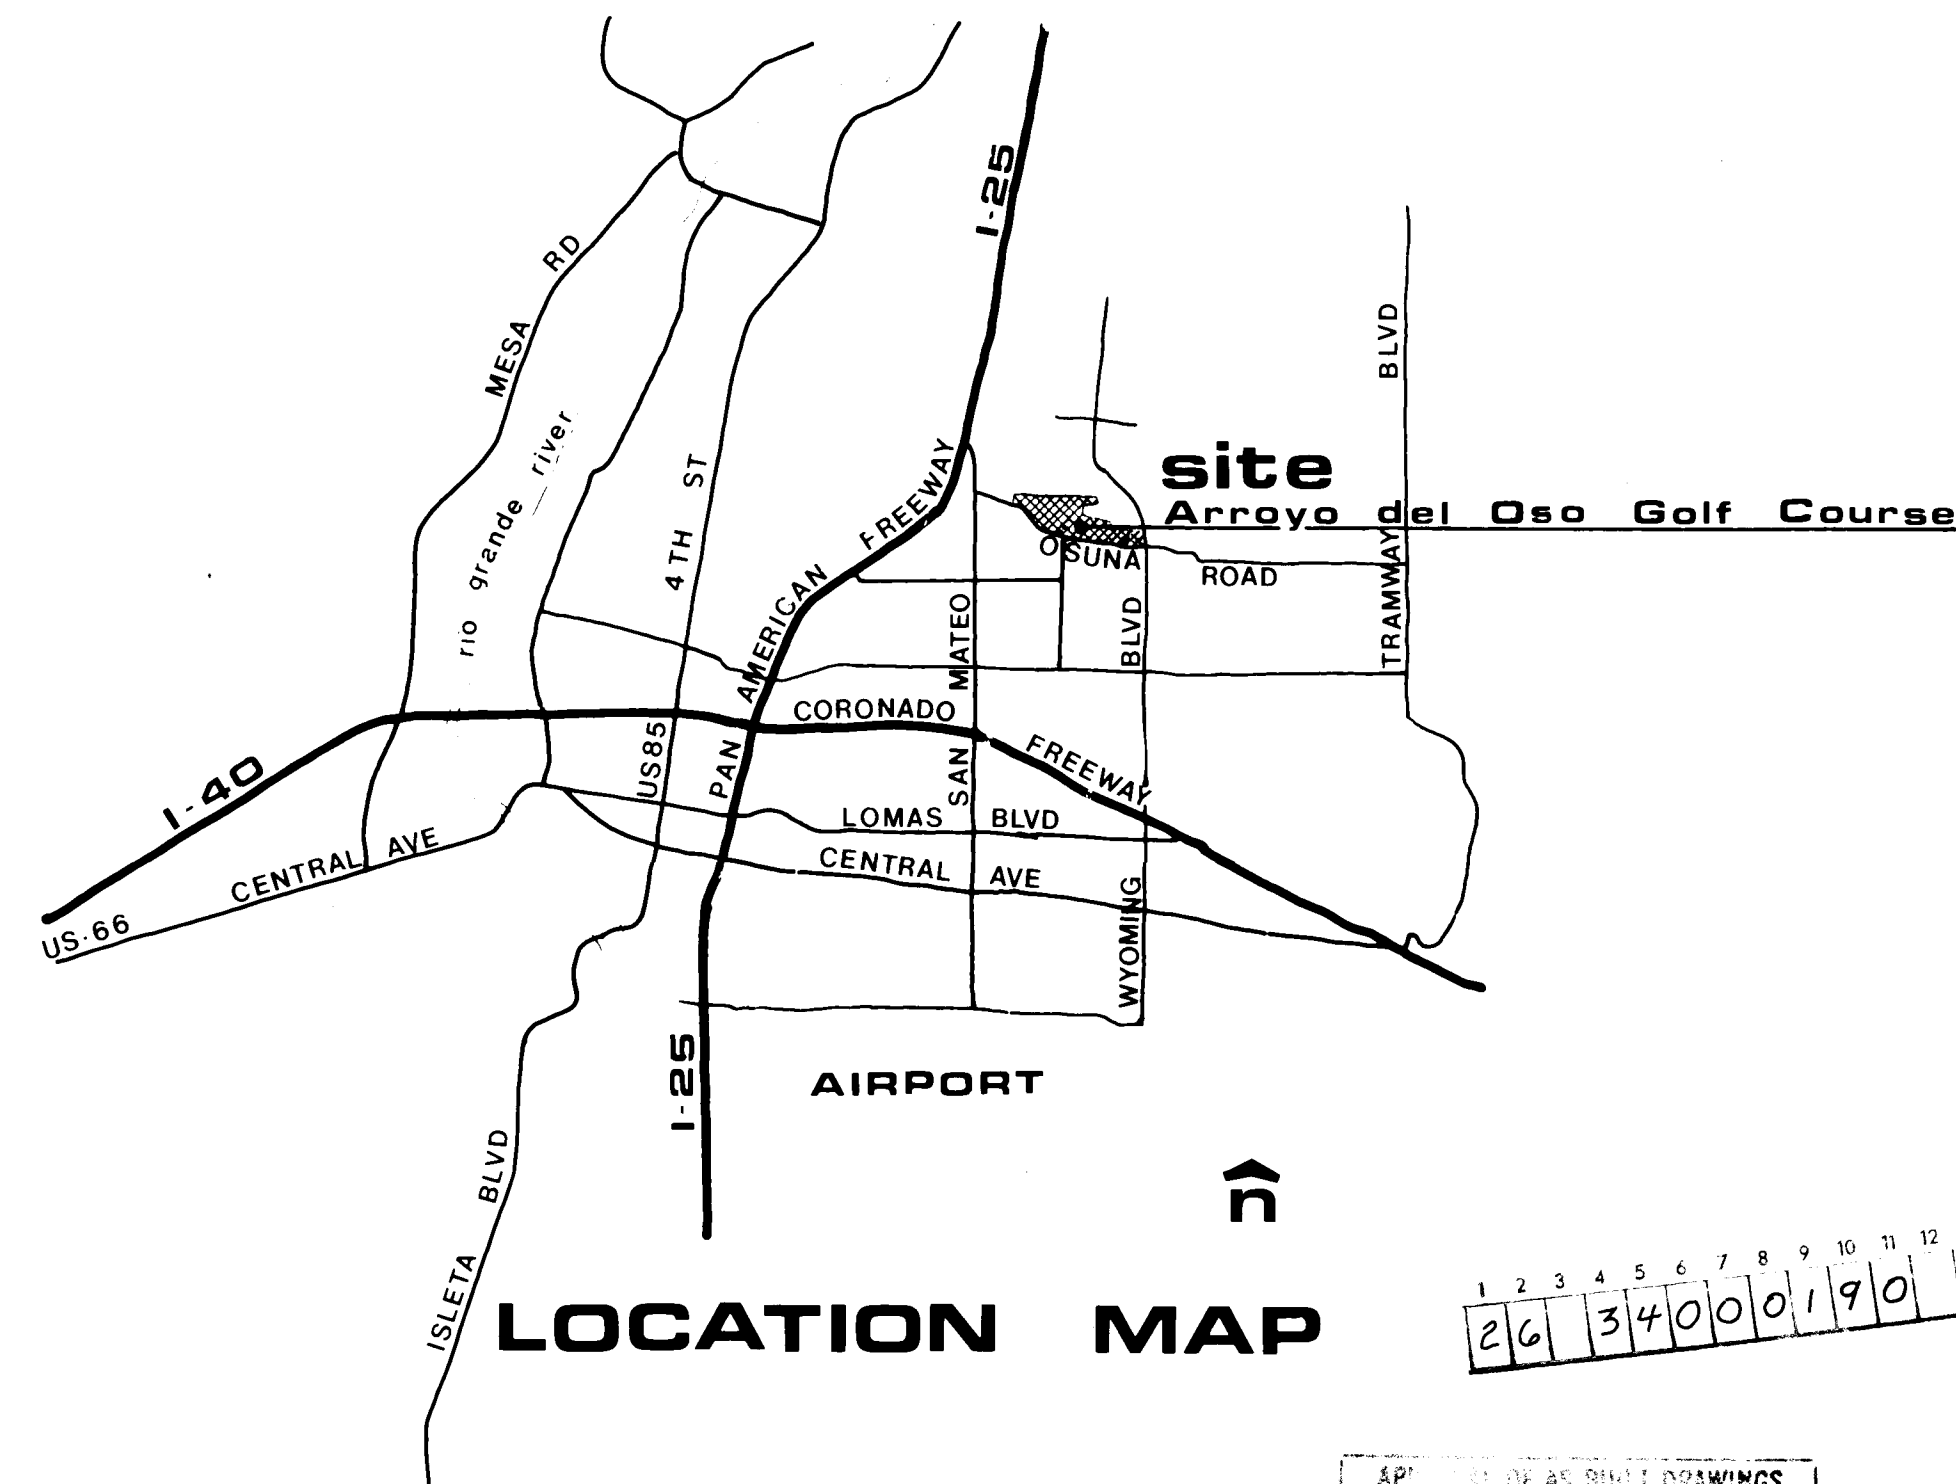

LOCATION MAP

1 2 3 4 5 6 7 8 9 10 11 12
26 34 00 01 90

APPROVED FOR AS BUILT DRAWINGS
CHIEF CONSTRUCTION ENGINEER
[Signature]
1-18-98


[Signature]
REGISTERED
LANDSCAPE ARCHITECT
172

INDEX

TITLE SHEET	TS1
FIELD CONTROL PLAN	FC1
GRADING PLAN	G1
GREEN DETAILS 1 & 2	GD1
" 3 & 8	GD2
" 4	GD3
" 5	GD4
" 6	GD5
" 7 & 9	GD6
CONSTRUCTION DETAILS	CD1
"	CD2
"	CD3
DROP STRUCTURES	I1
IRRIGATION PLAN	I2
POND CONNECTIONS	PP1
PLANTING PLAN/ART PATHS	S1
SEEDING PLAN	S1

REV	SHEET	CITY ENGINEER	DATE	USER	DEPT.	DATE	USER	DEPT.	DATE

ENGINEER'S SEAL & SIGNATURE	LOGO	APPROVED FOR CONSTRUCTION <i>[Signature]</i> 1-18-98
	PROJECT NUMBER 3400	SHEET 1 OF 16

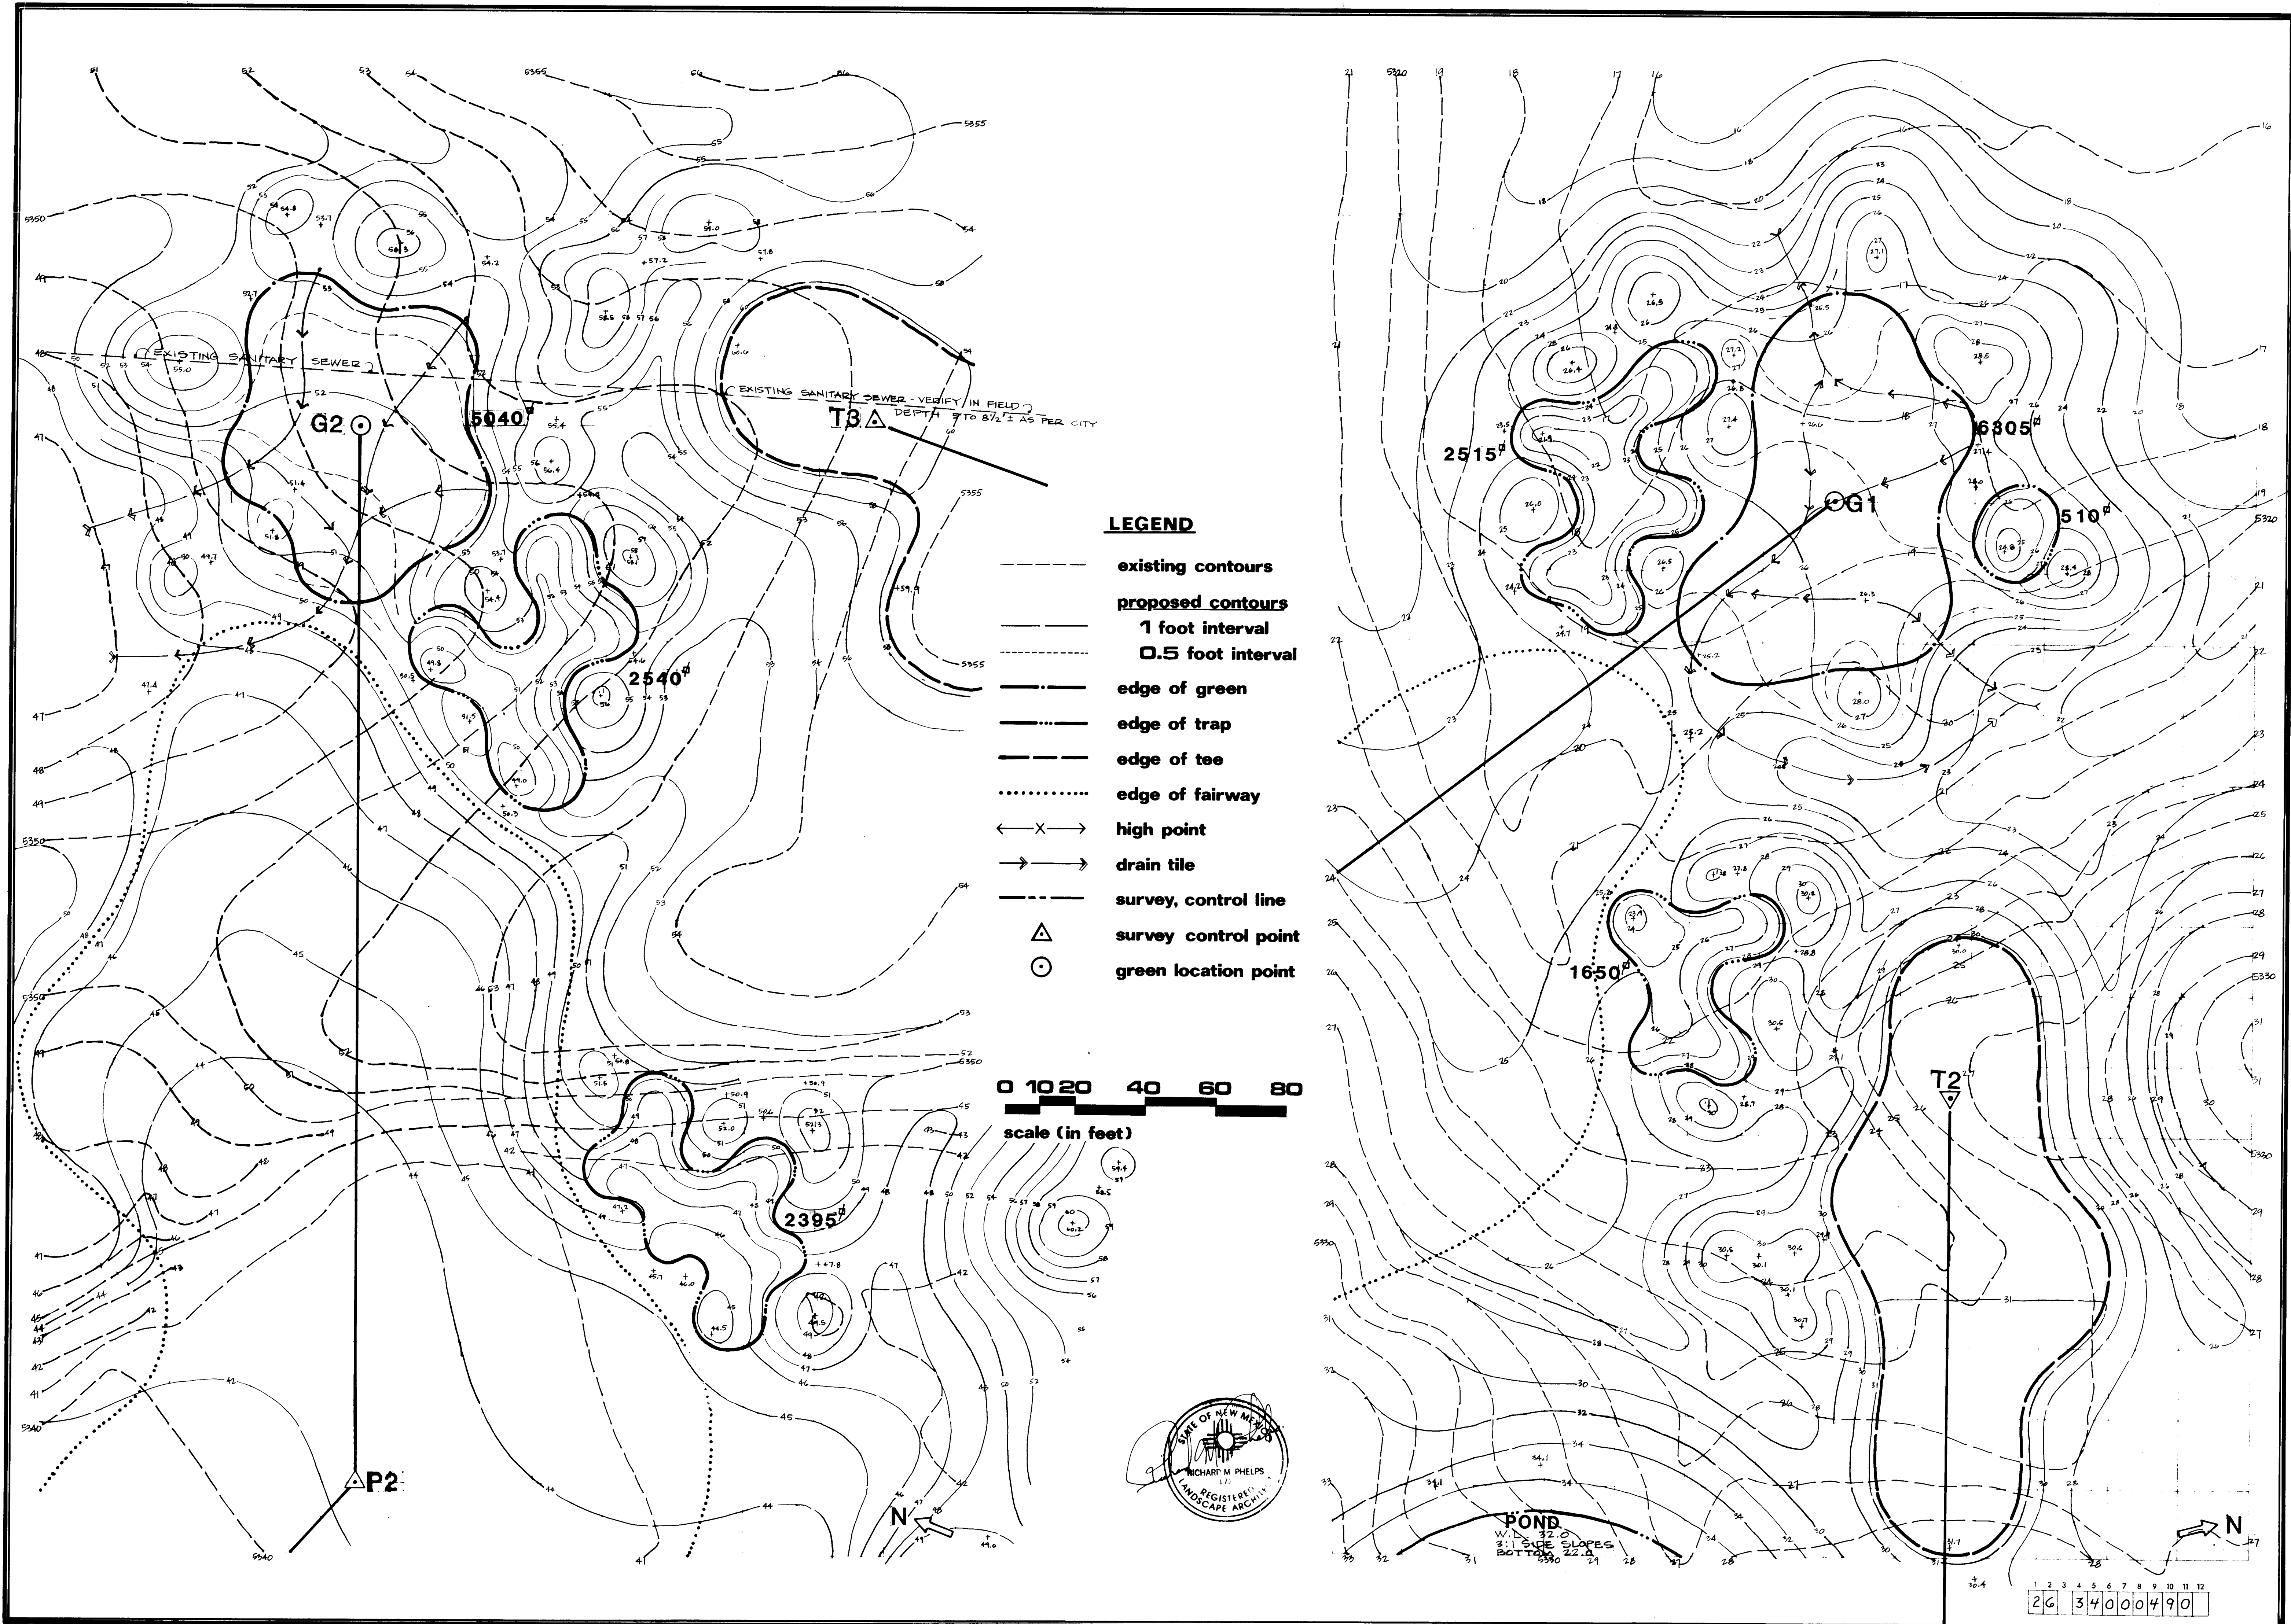


RICHARD M. PHELPS
GOLF COURSE ARCHITECT
 P.O. Box 3285
 Evergreen, Colorado 80439

ARROYO DEL OSO GOLF COURSE
ALBUQUERQUE, NEW MEXICO

#1 GREEN
#2 TEE
#2 GREEN
#3 TEE

sheet
GD 1
4 of 16

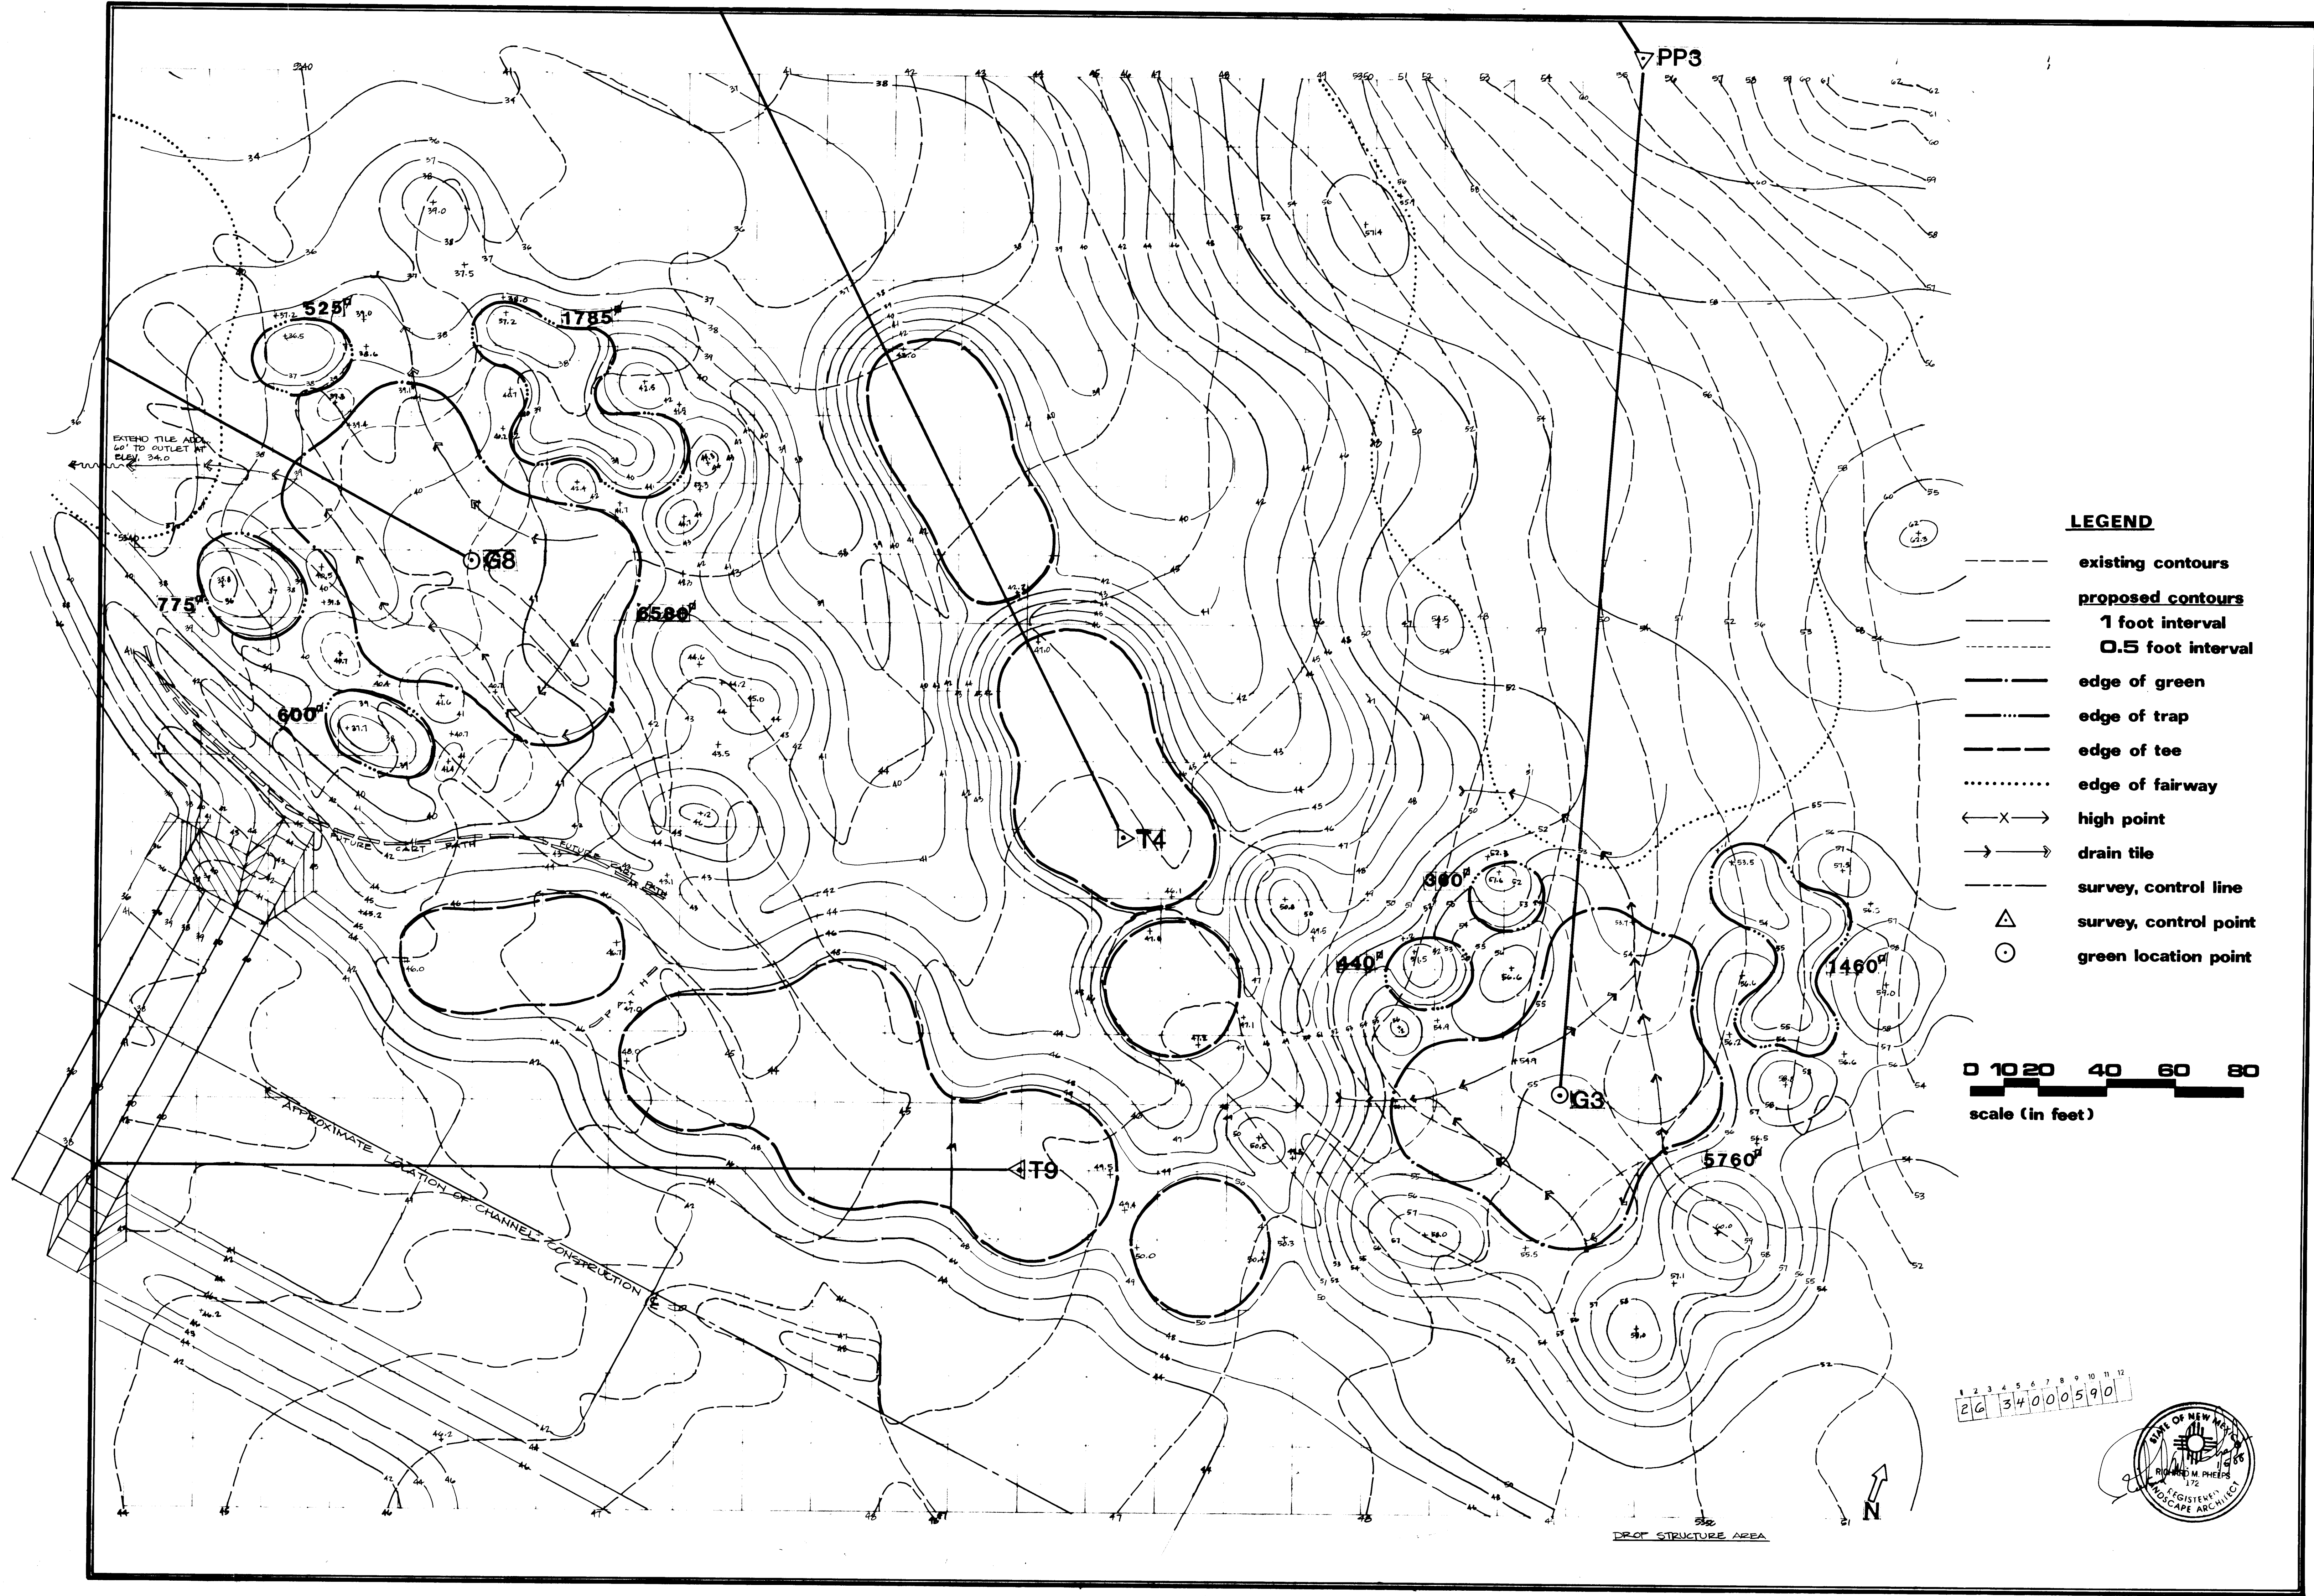

LEGEND

- existing contours
- proposed contours
- 1 foot interval
- 0.5 foot interval
- edge of green
- edge of trap
- edge of tee
- edge of fairway
- high point
- drain tile
- survey, control line
- survey, control point
- green location point


0 10 20 40 60 80
scale (in feet)


RICHARD M. PHELPS
GOLF COURSE ARCHITECT
P.O. Box 3285
Evergreen, Colorado 80439

ARROYO DEL OSO GOLF COURSE
ALBUQUERQUE, NEW MEXICO

job no. 10/1/87
drawn by EP
date 10/1/87
checked
revised 11/87
#3 GREEN,
#4 TEE,
#8 GREEN,
#9 TEE

sheet
GD2


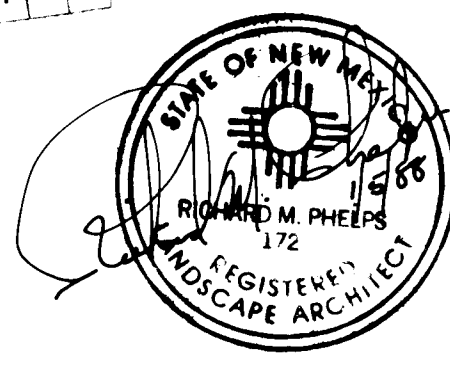


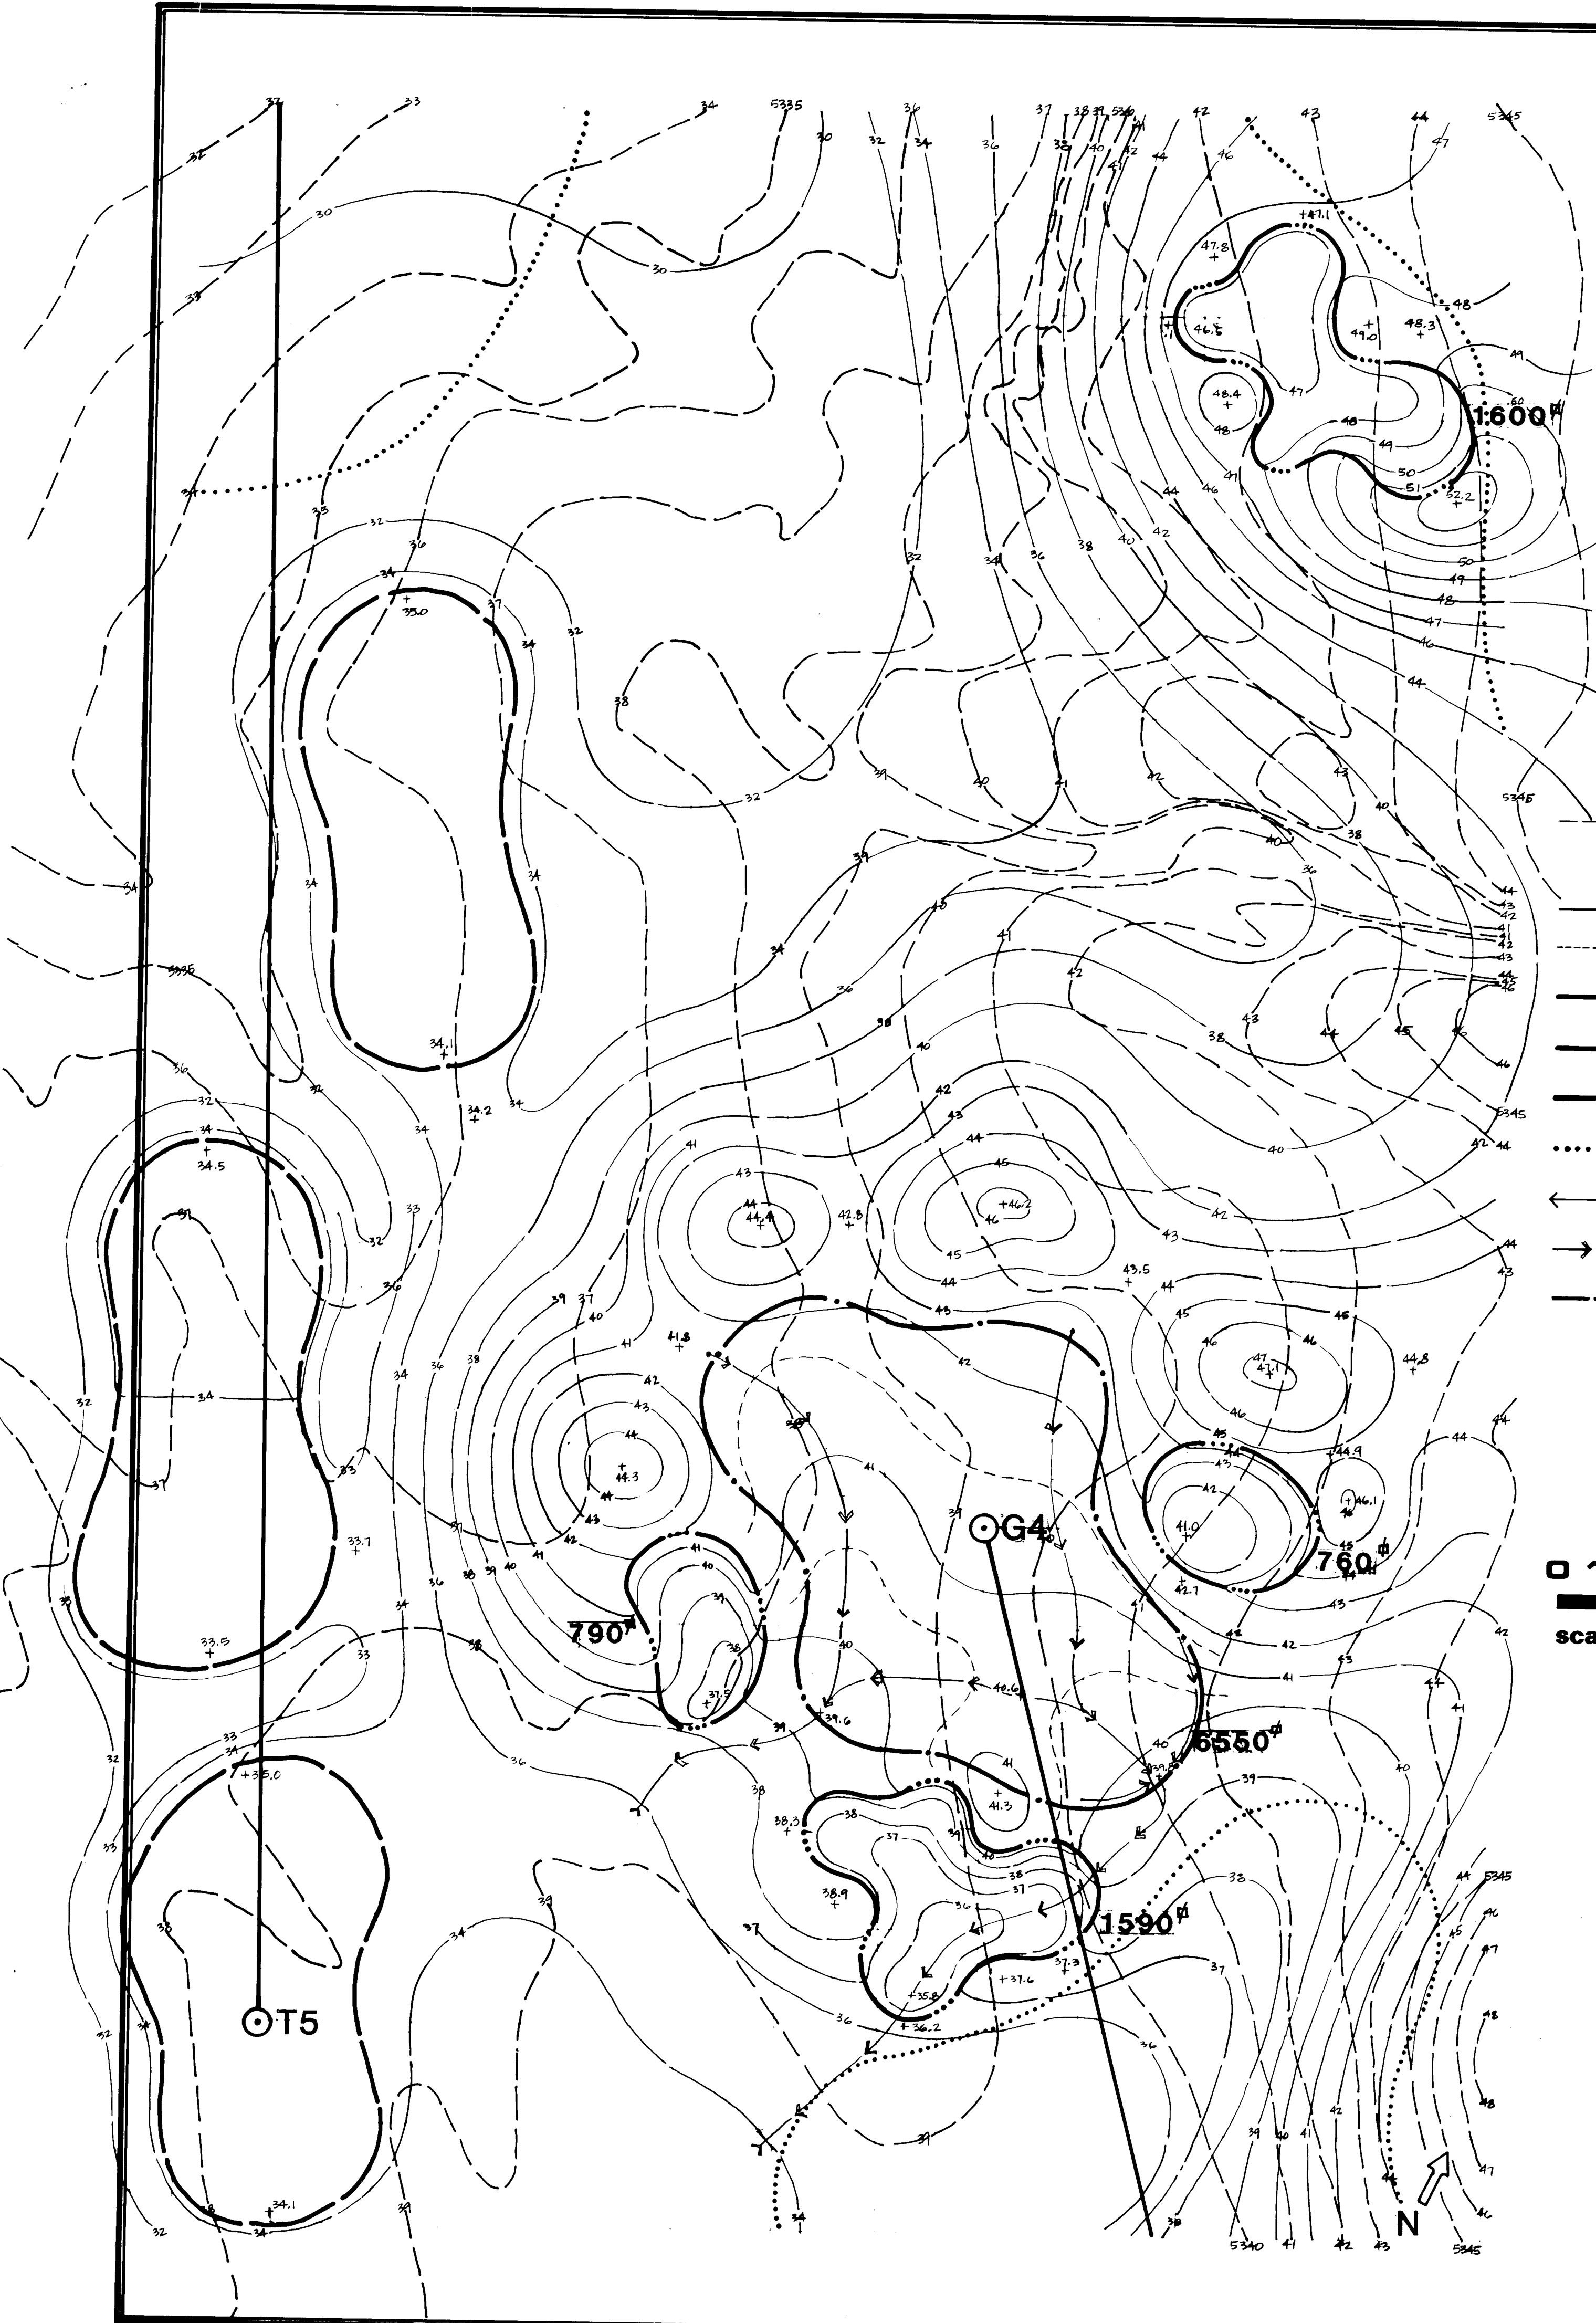

LEGEND

- existing contours
- proposed contours
- 1 foot interval
- 0.5 foot interval
- edge of green
- edge of trap
- edge of tee
- edge of fairway
- ← X → high point
- → drain tile
- survey, control line
- △ survey control point
- green location point

0 10 20 40 60 80
scale (in feet)

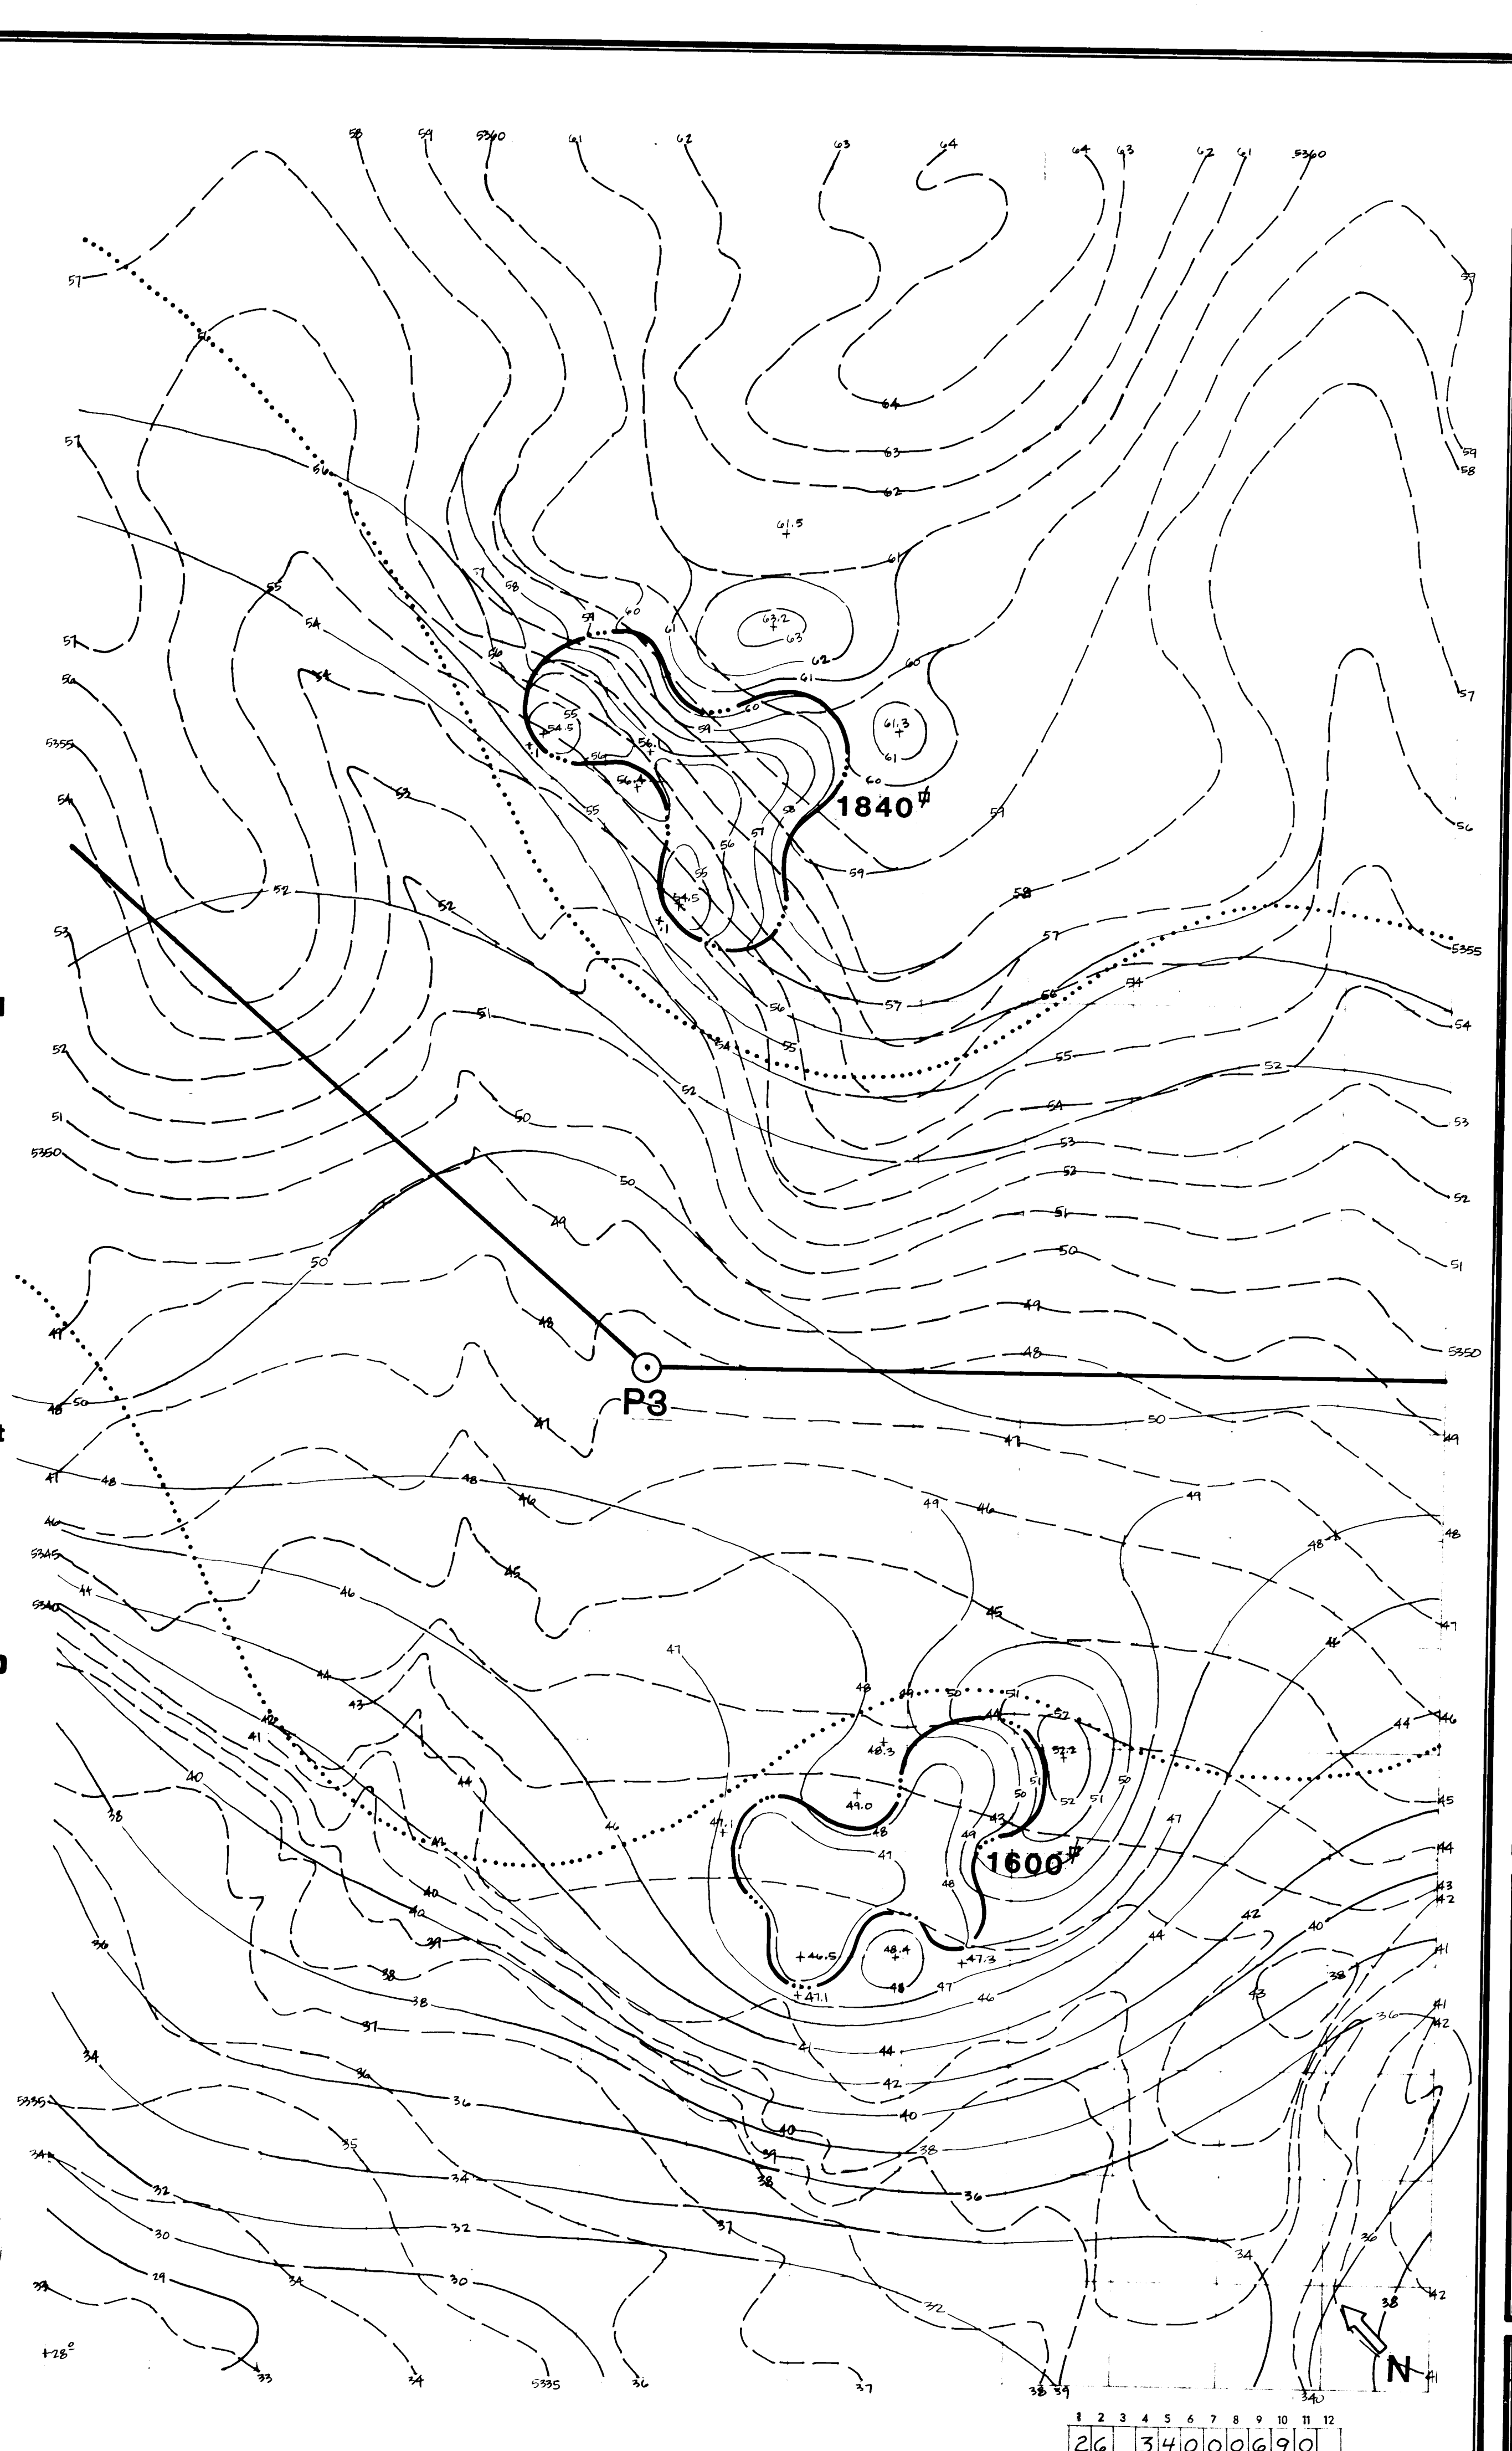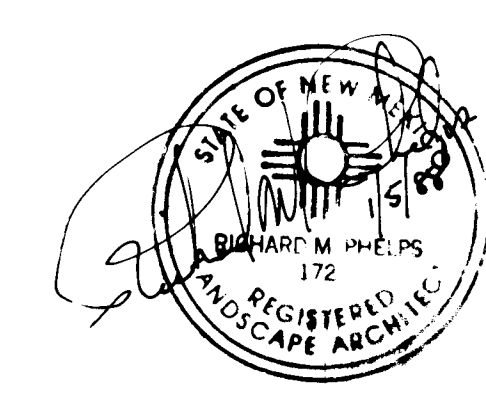


ARROYO DEL OSO GOLF COURSE
ALBUQUERQUE, NEW MEXICO

RICHARD M. PHELPS
GOLF COURSE ARCHITECT
P.O. Box 3985
Evergreen, Colorado 80439

job no.	drawn by	date	checked	revised
#3 FAIRWAY	CP	9/81		
#4 GREEN				
#5 TEE				


sheet
GD3
26 340000690

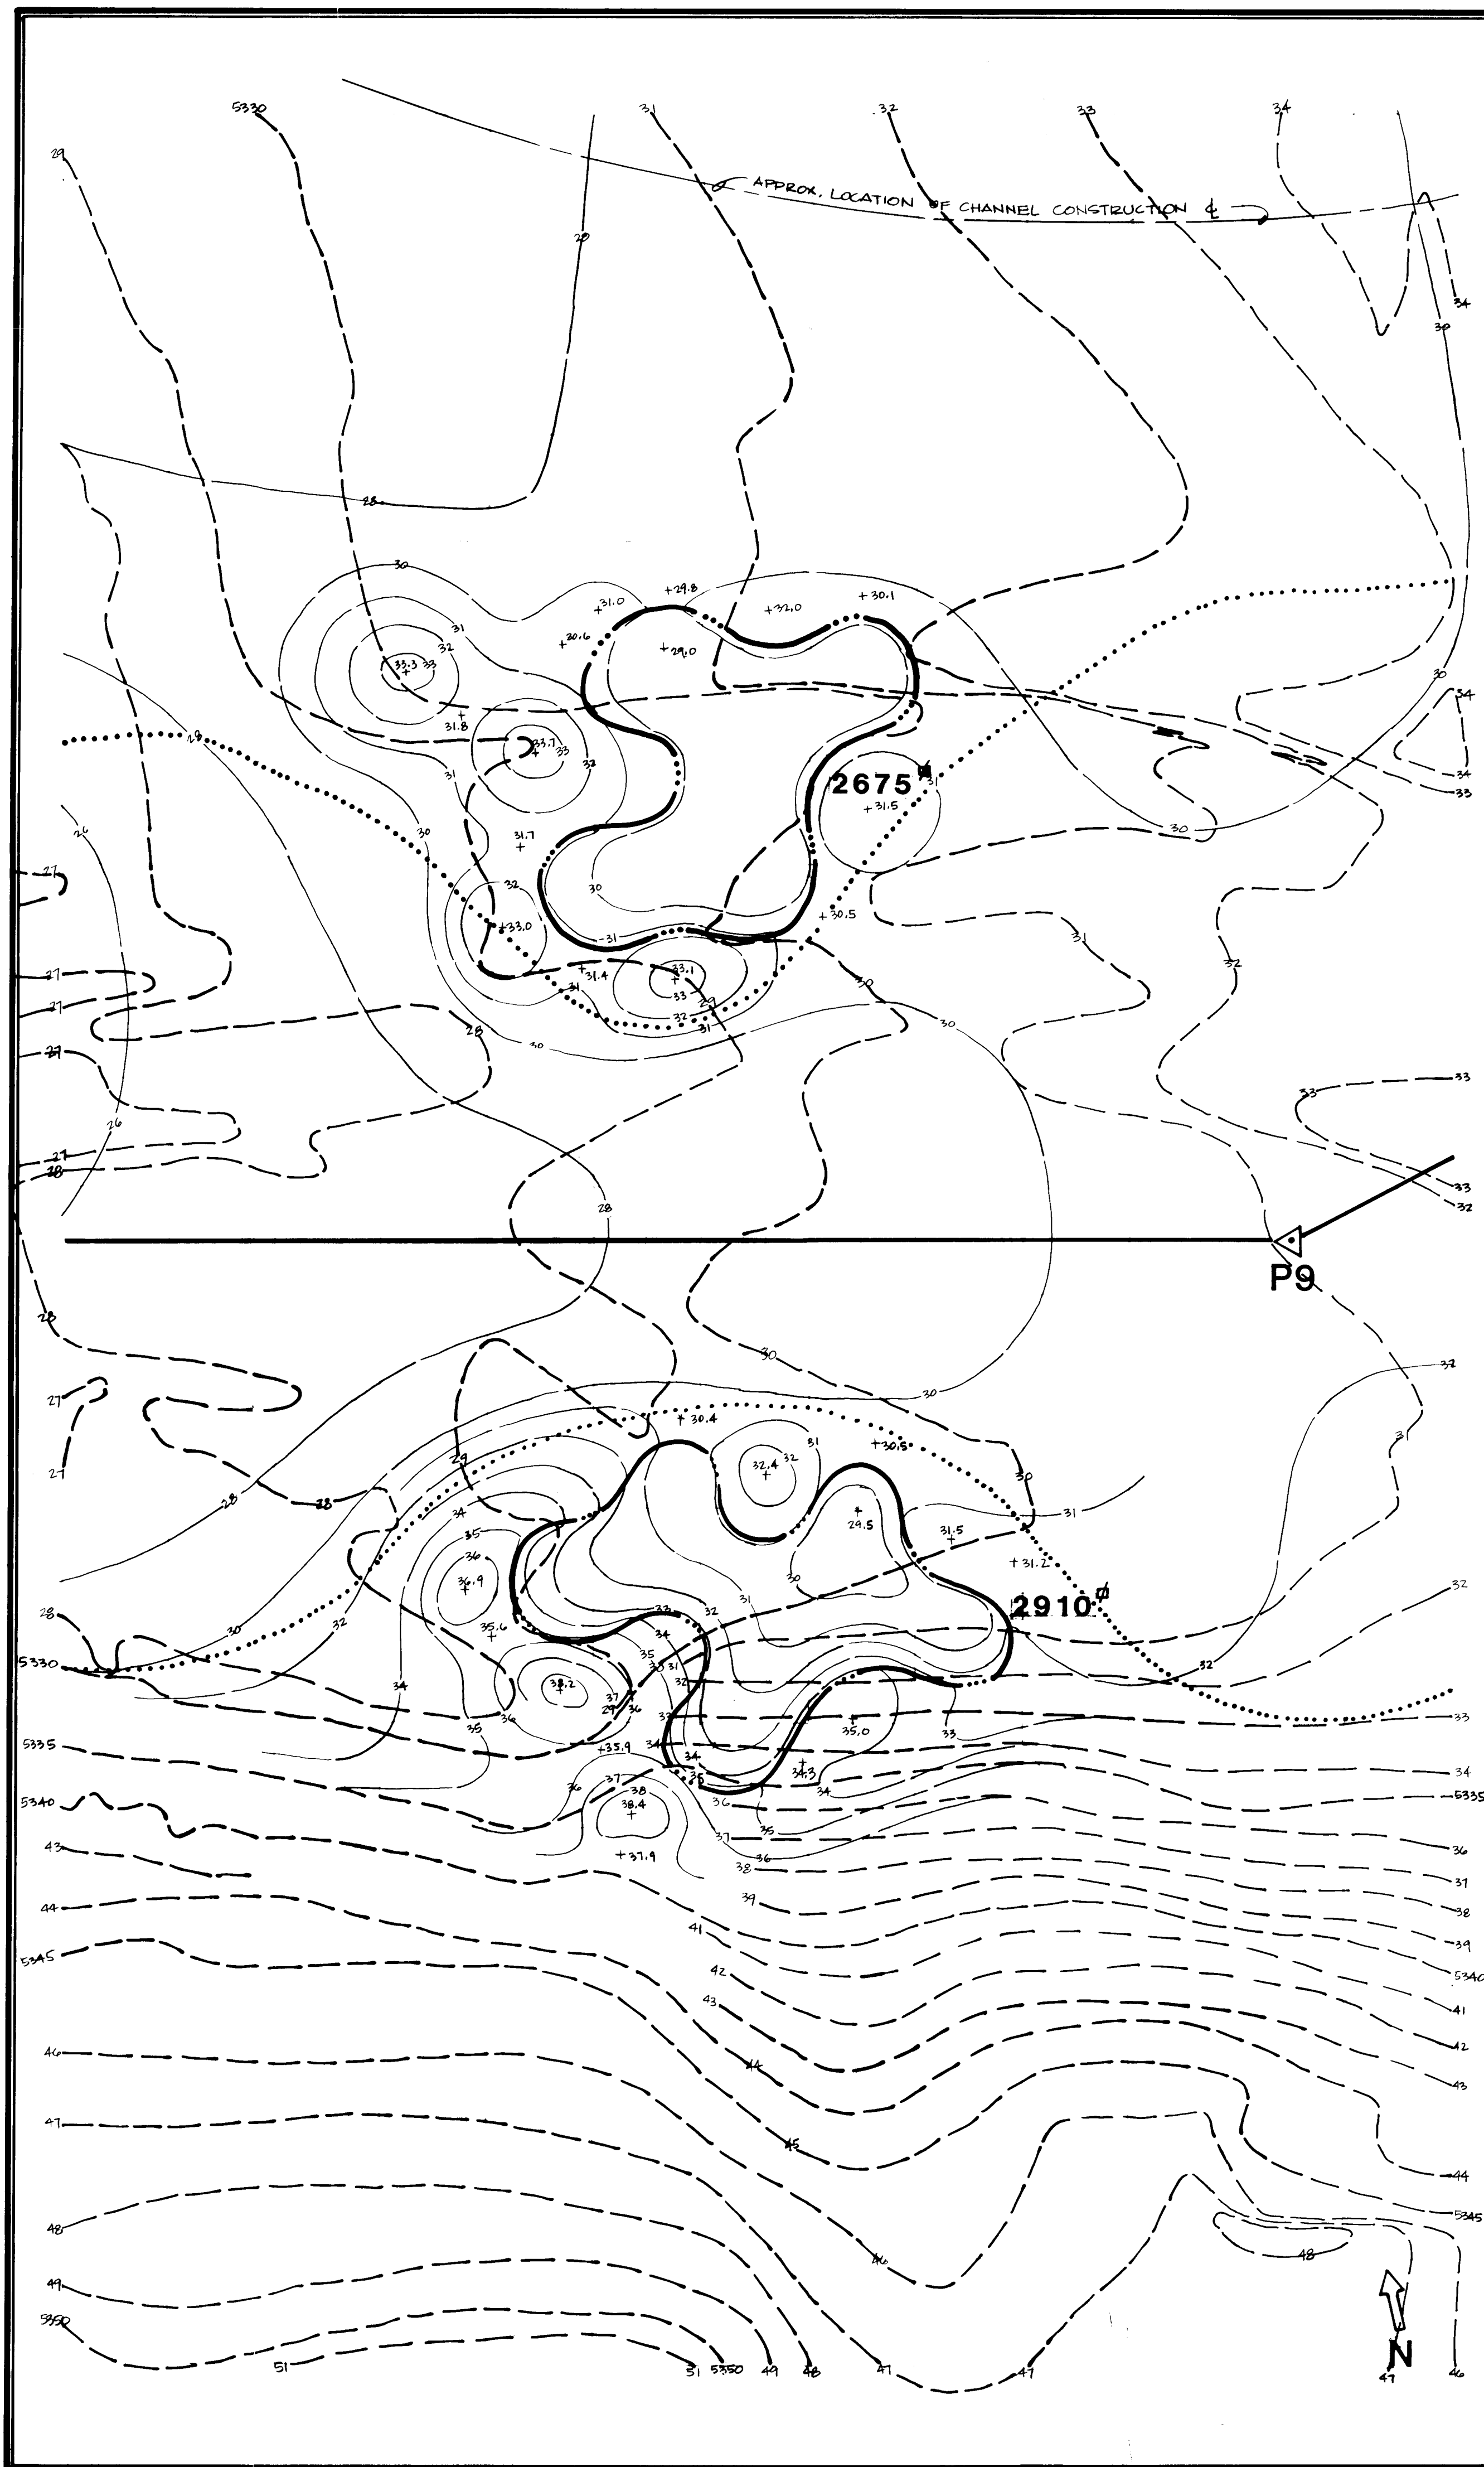

LEGEND

- existing contours
- proposed contours
- 1 foot interval
- 0.5 foot interval
- edge of green
- edge of trap
- edge of tee
- edge of fairway
- ← X → high point
- → → drain tile
- survey, control line
- △ survey control point
- green location point

0 10 20 40 60 80
scale (in feet)

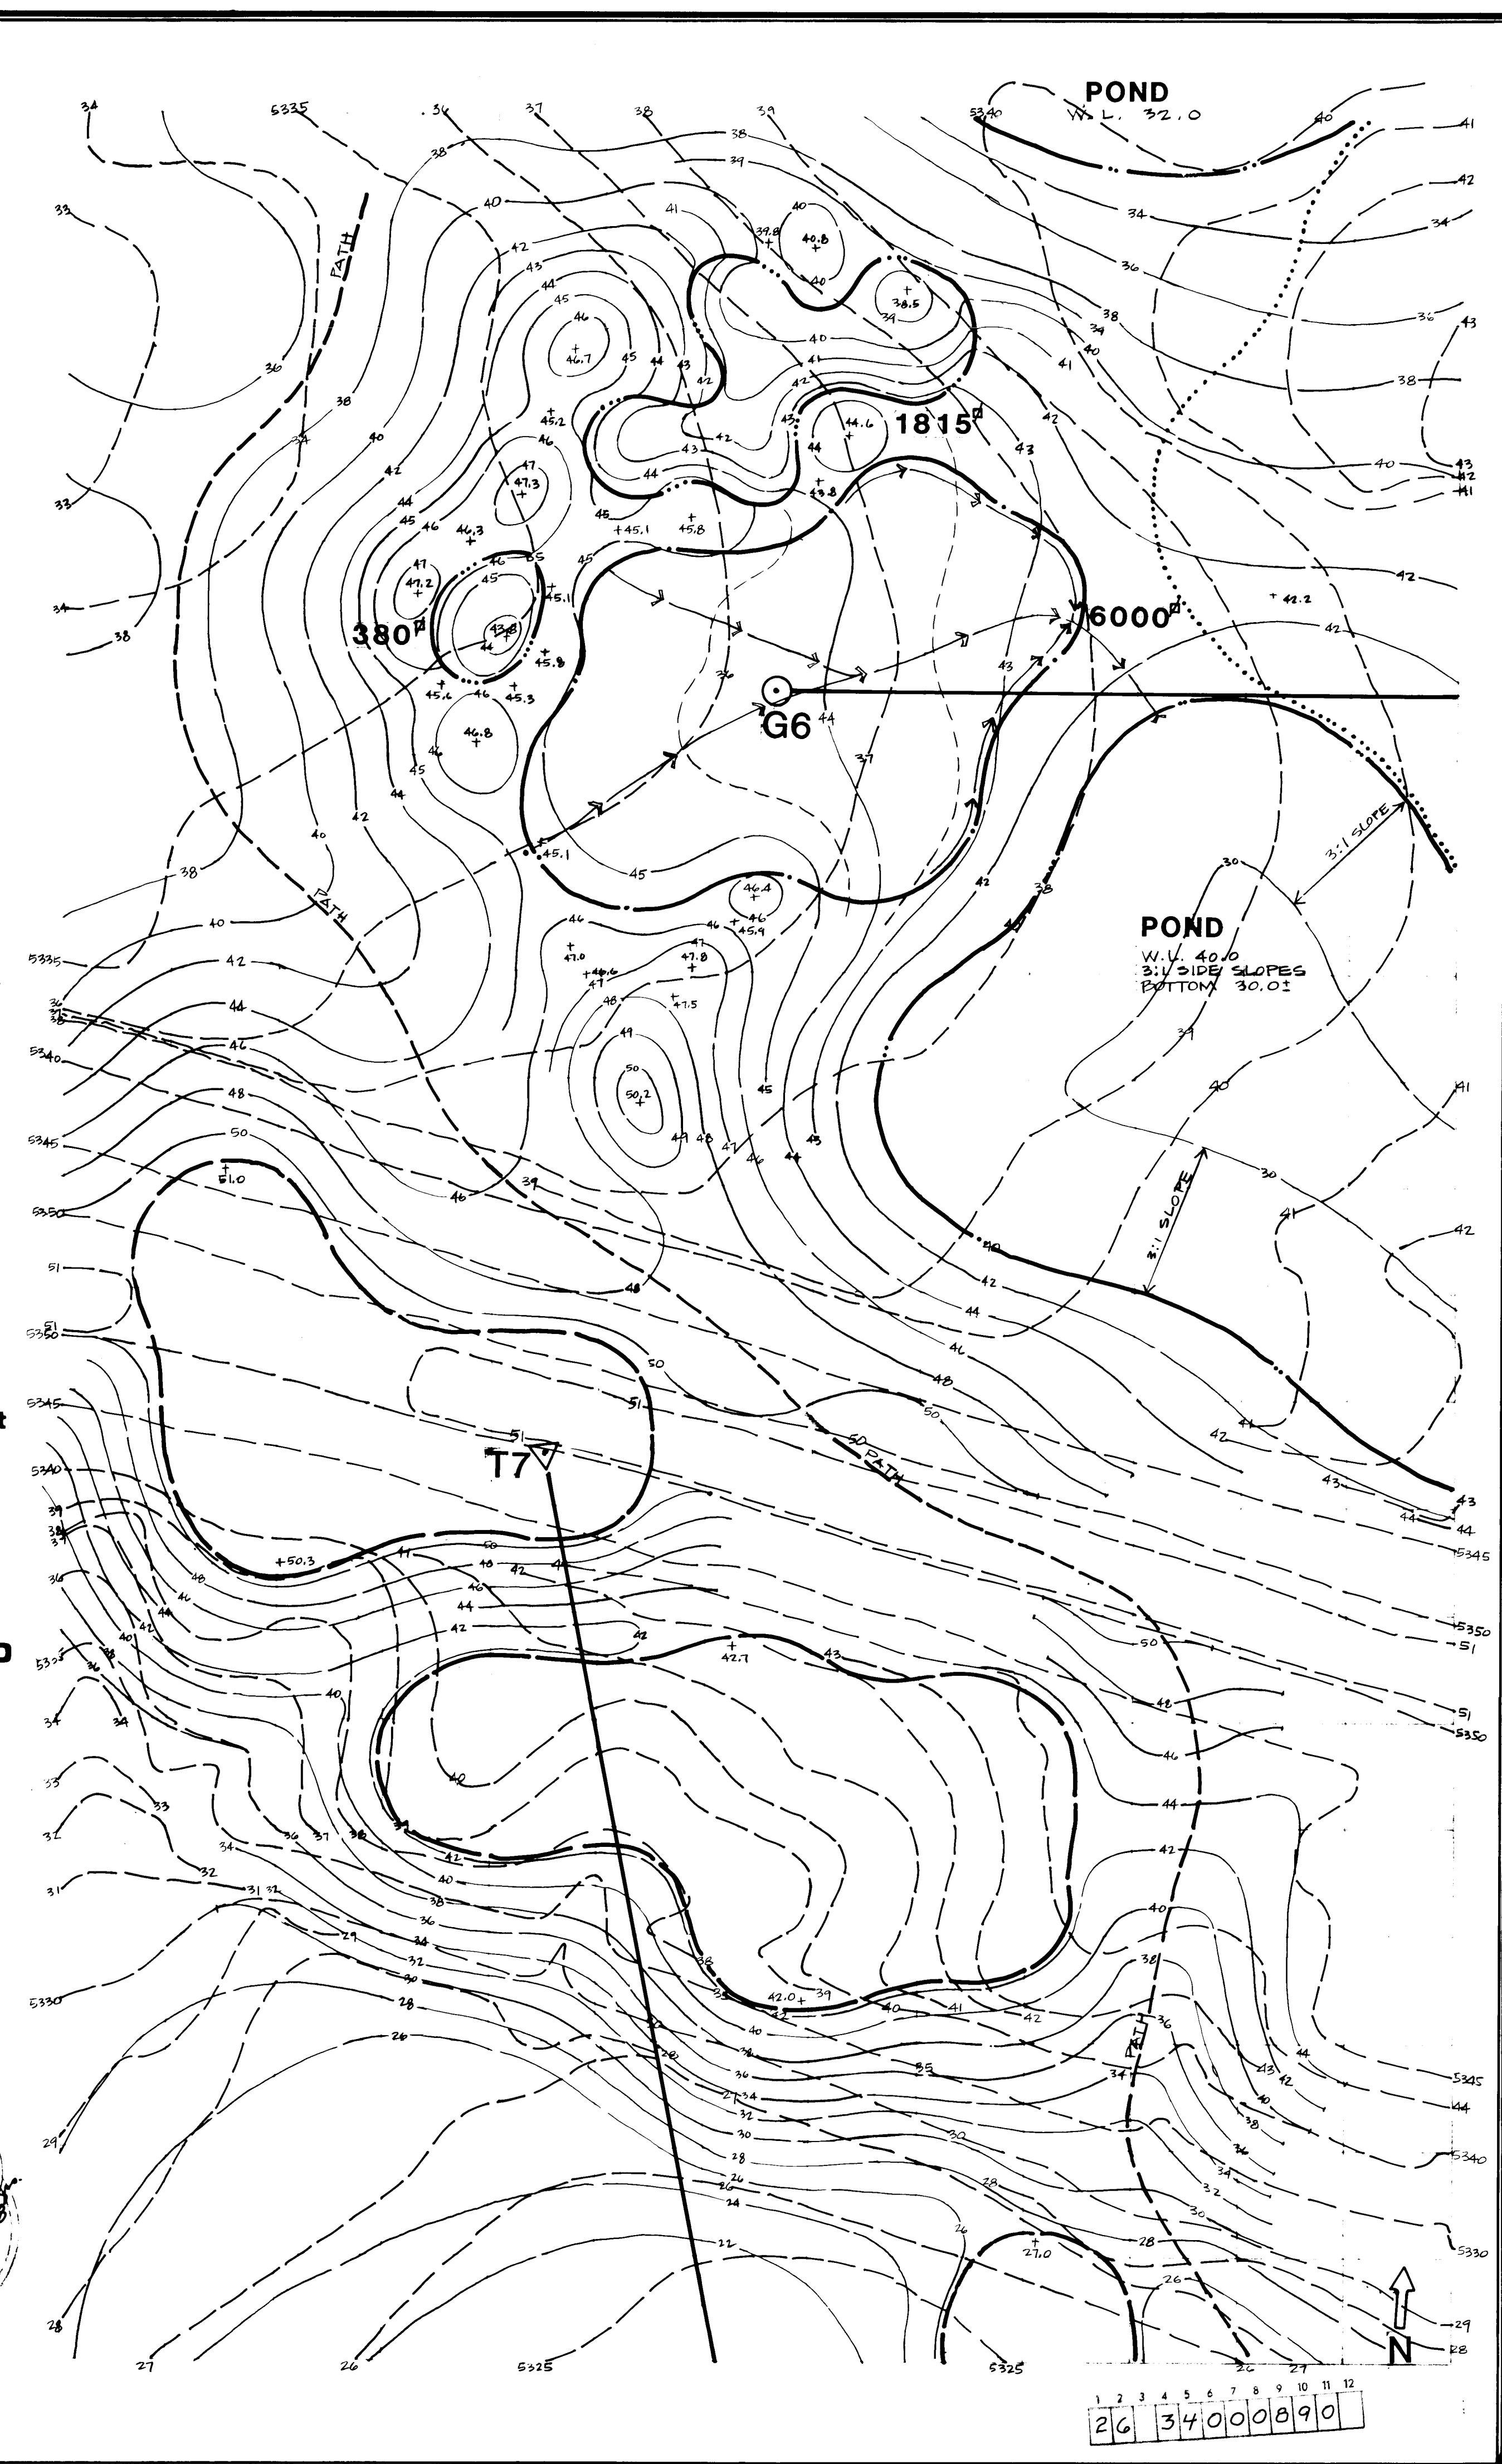

1	2	3	4	5	6	7	8	9	10	11	12
26	34	00	08	90							


RICHARD M. PHELPS
GOLF COURSE ARCHITECT
P.O. Box 3295 Evergreen, Colorado 80439

ARROYO DEL OSO GOLF COURSE
ALBUQUERQUE, NEW MEXICO


#9 FAIRWAY
#6 GREEN
#7 TEE

job no. 10/467
drawn by
date 10/467
checked
revised 10/67 TUE
GARDNER


sheet
B 9 of 18
GD5

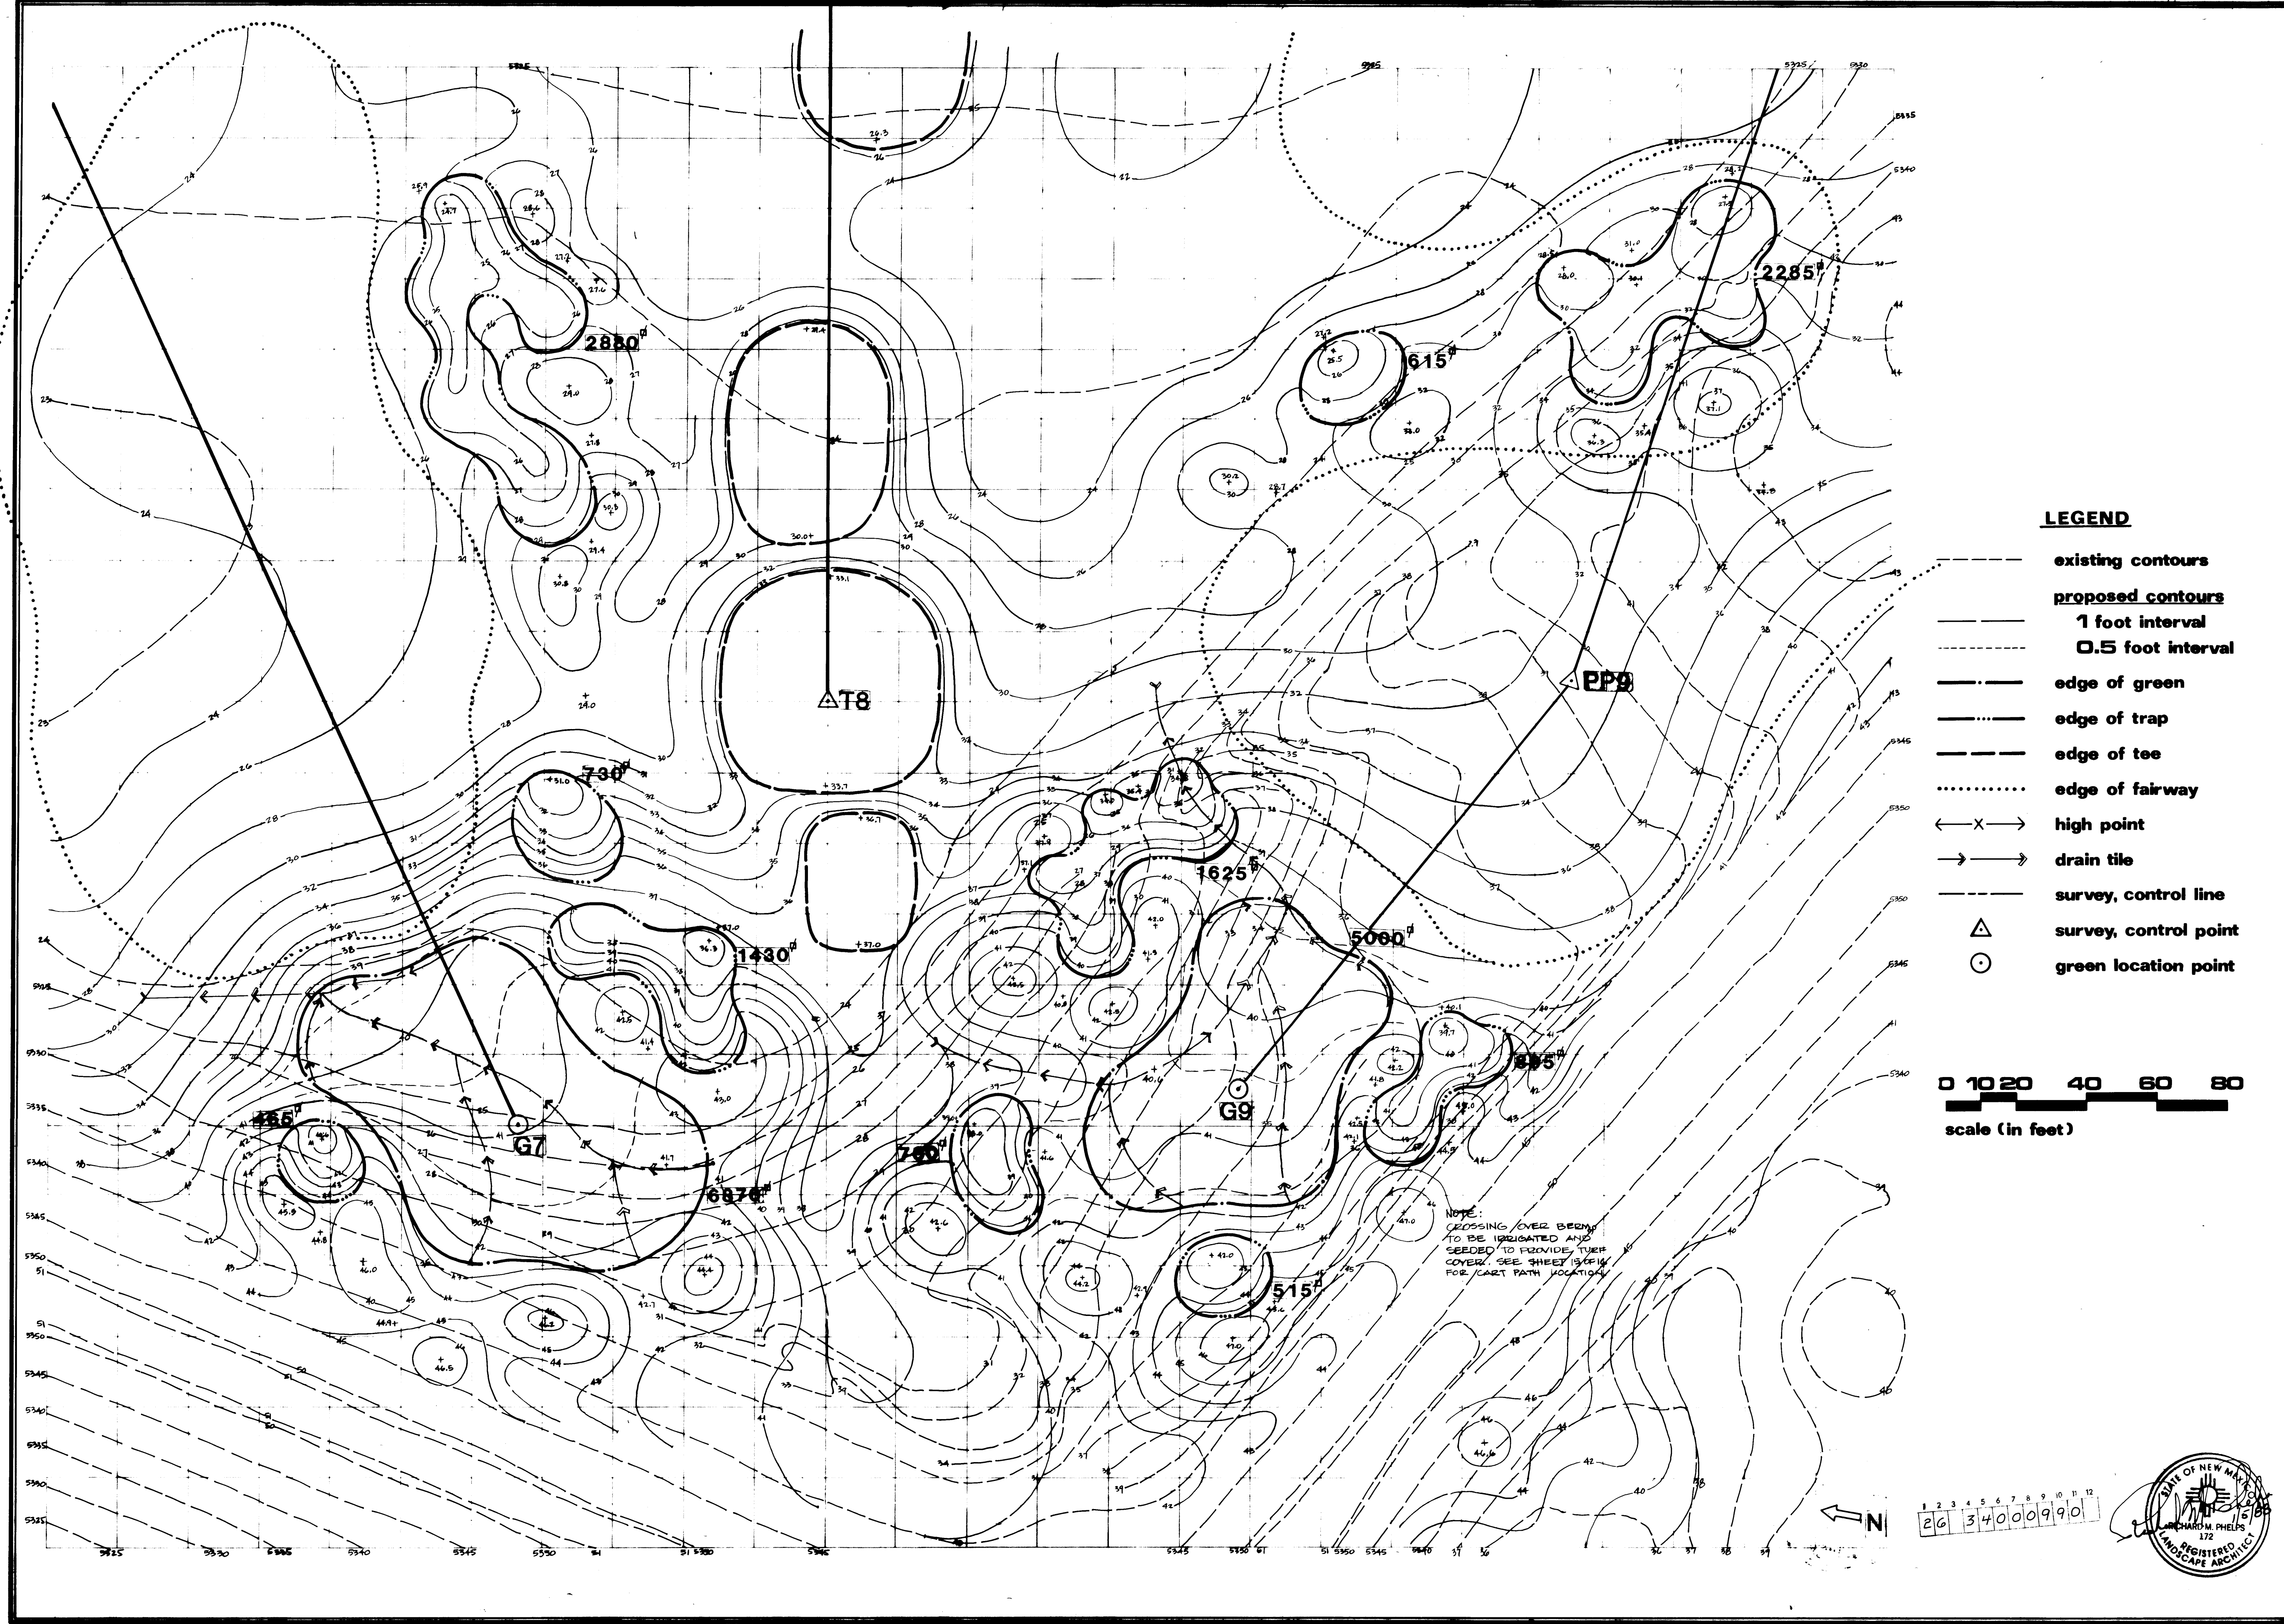

- LEGEND**
- existing contours
 - proposed contours
 - 1 foot interval
 - 0.5 foot interval
 - edge of green
 - edge of trap
 - edge of tee
 - edge of fairway
 - high point
 - drain tile
 - survey, control line
 - survey, control point
 - green location point

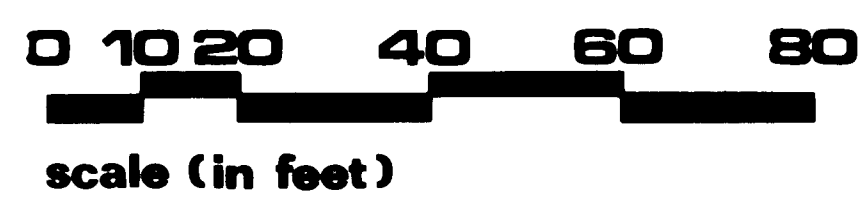

1 2 3 4 5 6 7 8 9 10 11 12
26 34000990

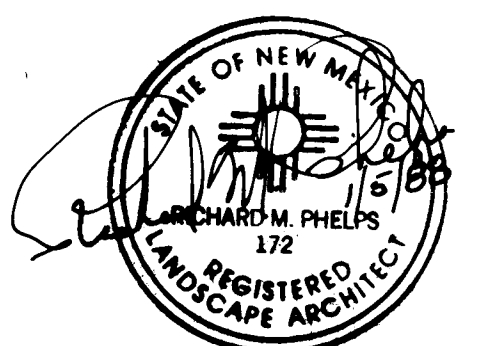


RICHARD M. PHELPS
GOLF COURSE ARCHITECT
P.O. Box 3285
Evergreen, Colorado 80439

ARROYO DEL OSO GOLF COURSE
ALBUQUERQUE, NEW MEXICO


job no.
drawn by
date 10/7/87
checked
revised 1/88

#7 GREEN
#8 TEE
#9 GREEN



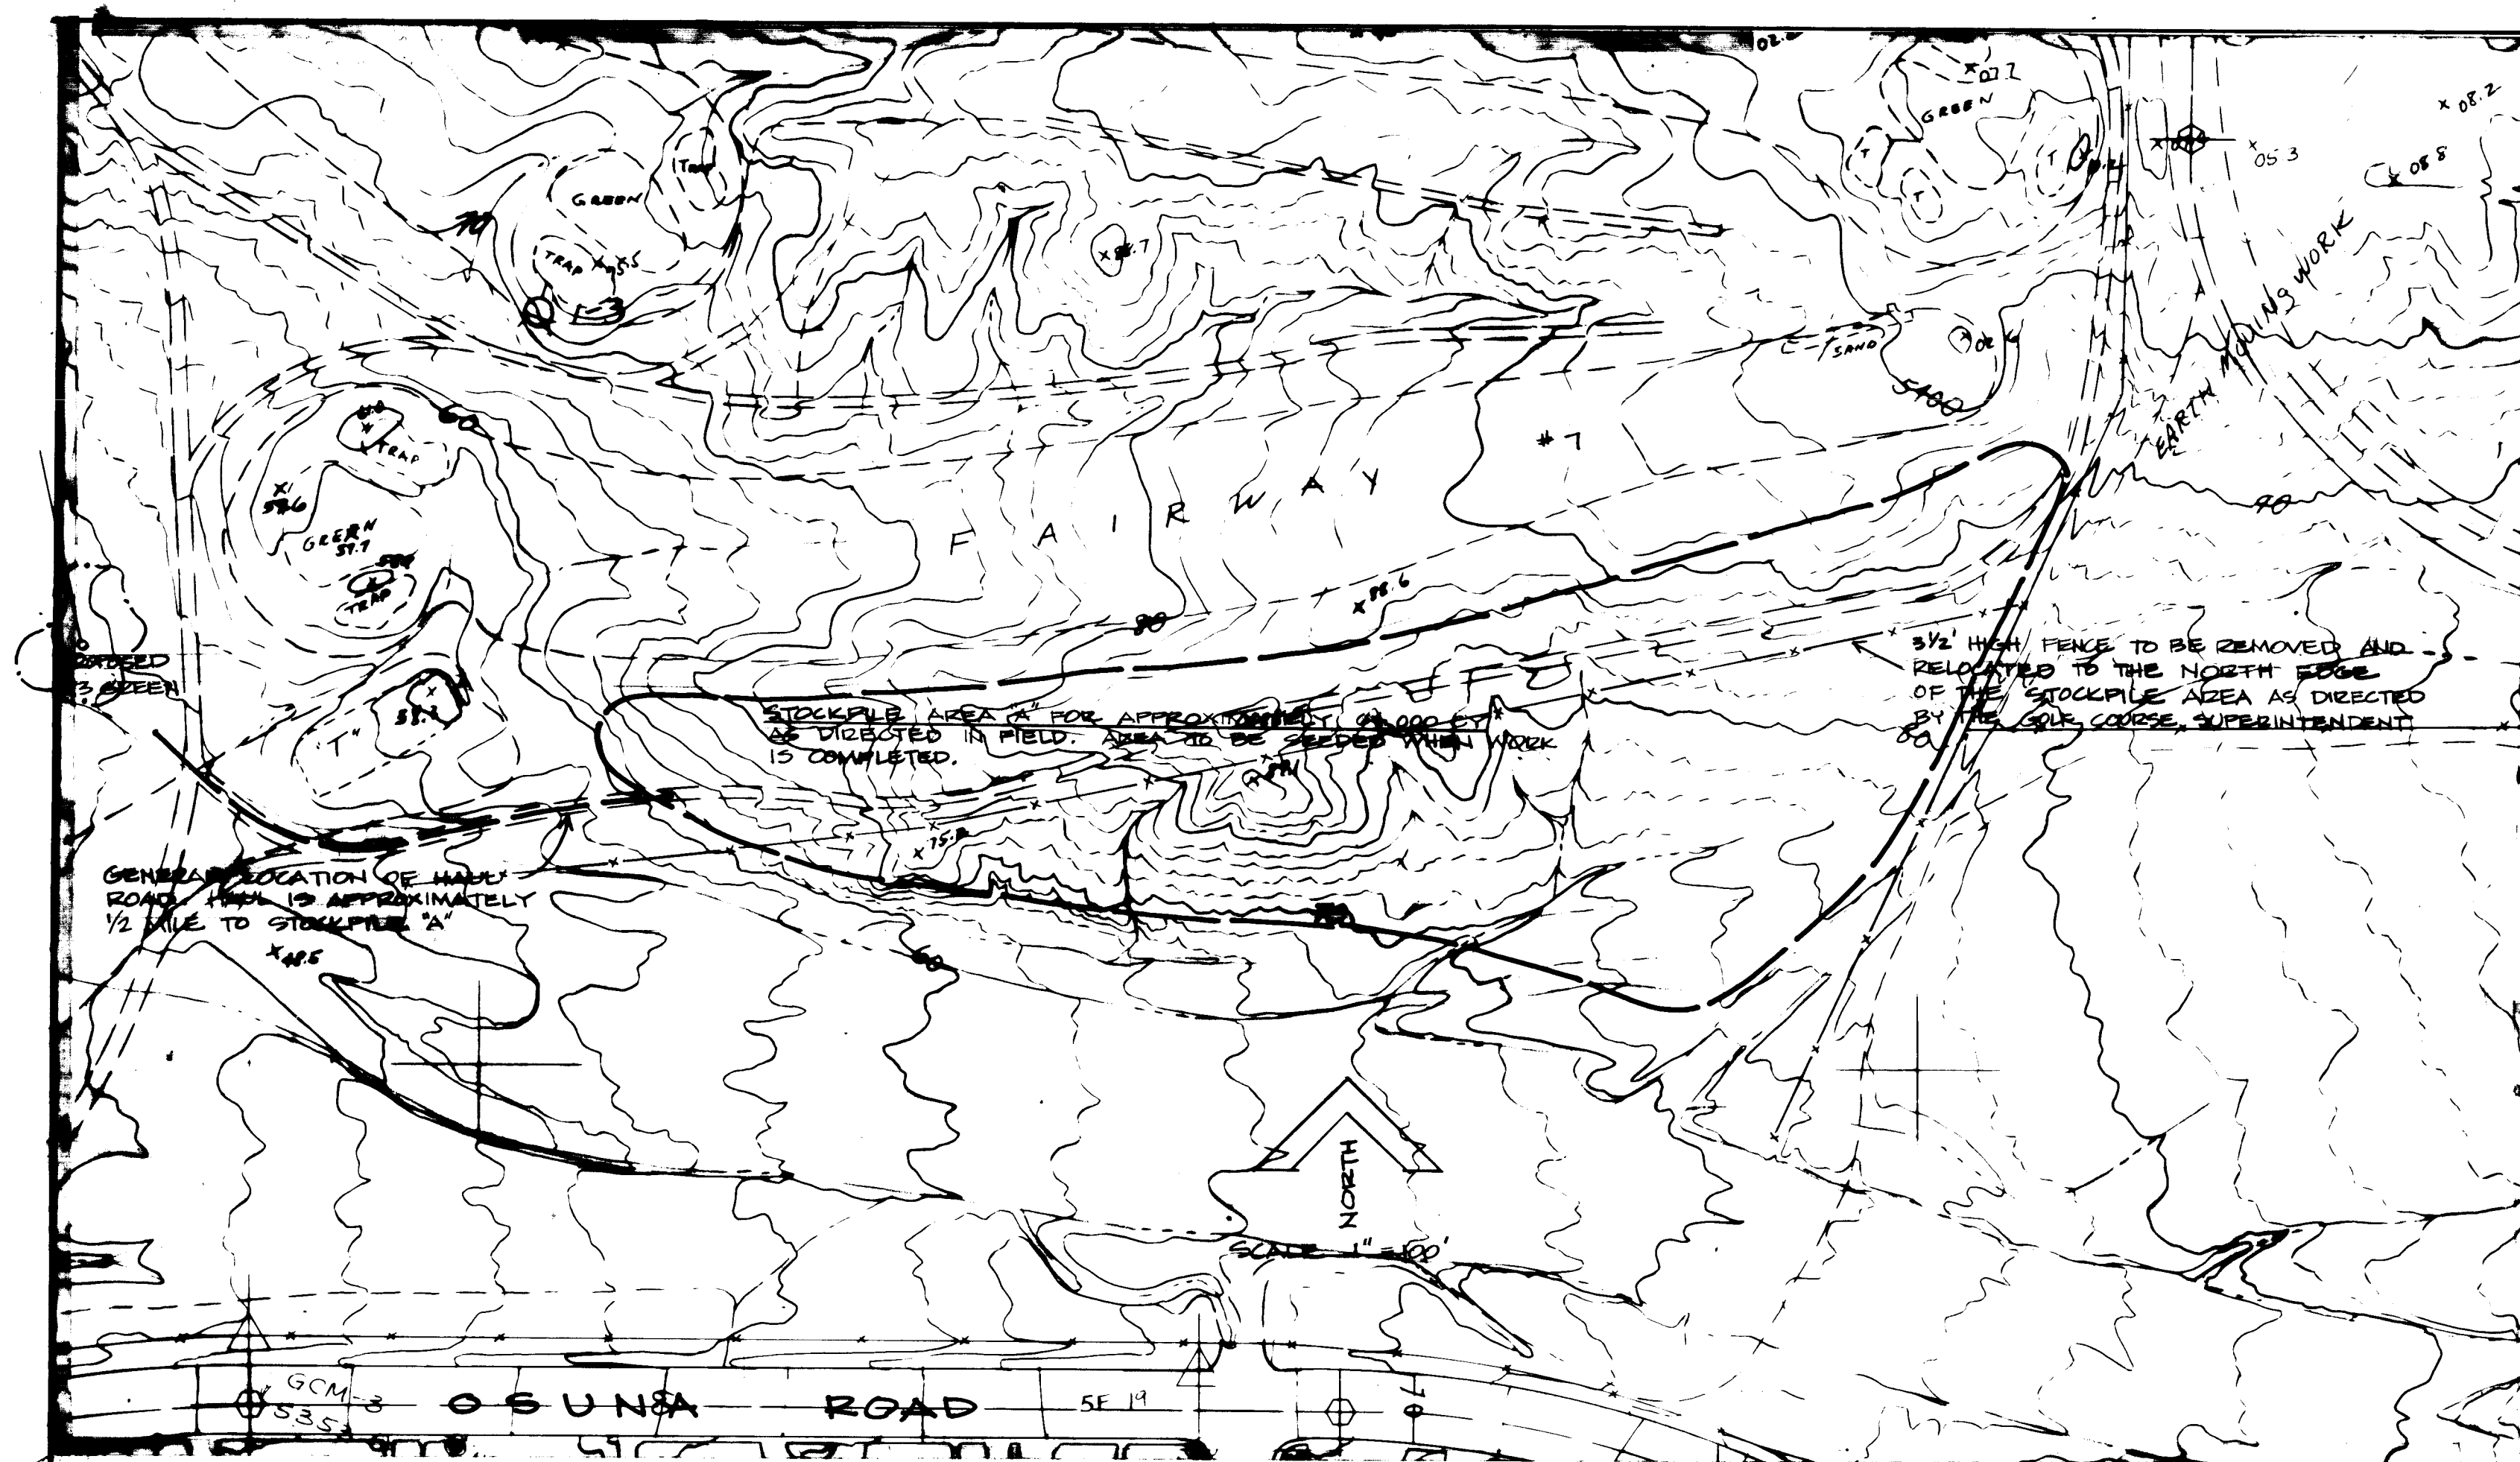

1 LOCATIONS FOR STOCKPILE AREA 'A'
SCALE 1" = 100'

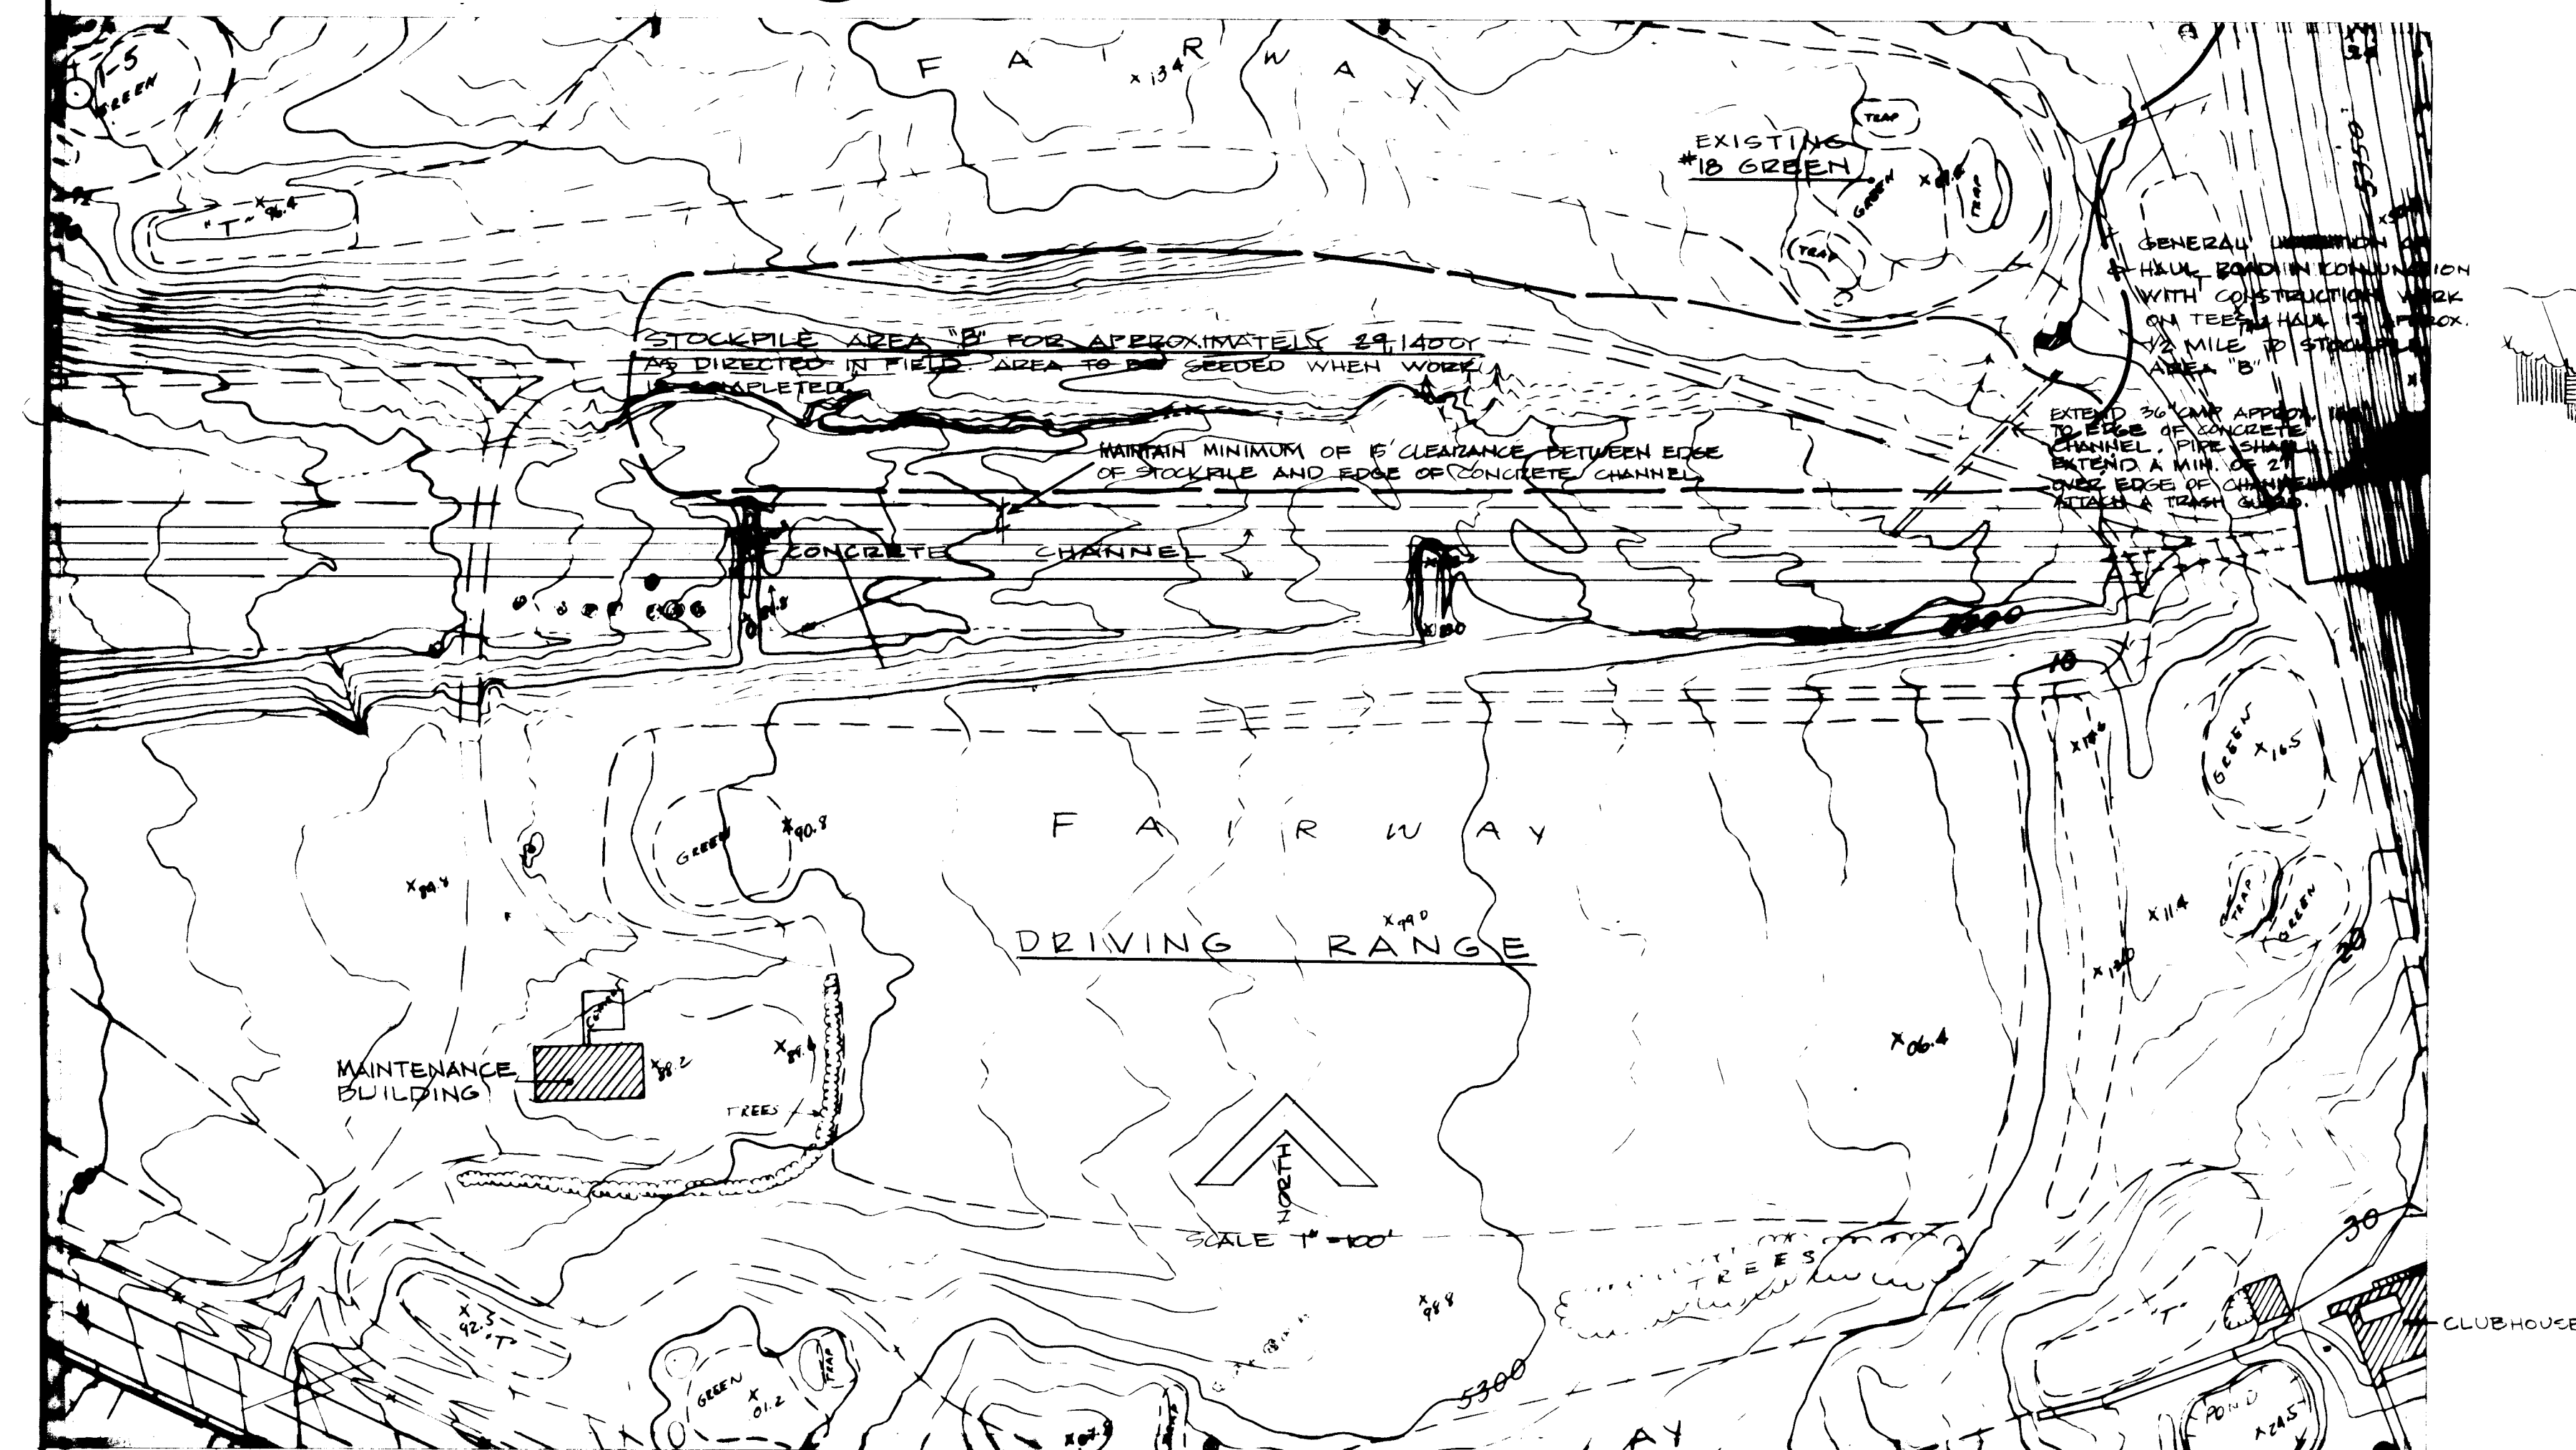



2 LOCATIONS FOR STOCKPILE AREA 'B'
SCALE 1" = 100'

NOTE - STOCKPILE AREA "A"


The material in this stockpile only is available to the Contractor for a period of two (2) years beyond the final date of acceptance of the project, for removal for his use in other projects, or for sale to other contractors and/or projects, at his sole discretion and under his control. The Contractor will be responsible for the control of access routes, dust control, safety, control over access to the material by fencing or other methods, and removal of the stockpiled material. Once all the material has been removed, and/or at the end of the two year period, the Contractor will be required to rip, disc and/or scarify all access roads and/or all compacted areas, bring all disturbed areas within the access roads and stockpile area to a seed-bed condition, apply seed, fertilizer and hydromulch (if slopes are greater than 5 to 1), and water until seed has adequately germinated.

At the end of the two year period, the remaining material in the stockpile will be the property of the City.

If the Contractor shall violate the conditions of this agreement at any time during the two year period, the City may deny access to the stockpiled material by the Contractor or any other parties he may have agreements with for removal of the material until acceptable corrective measures have been made.

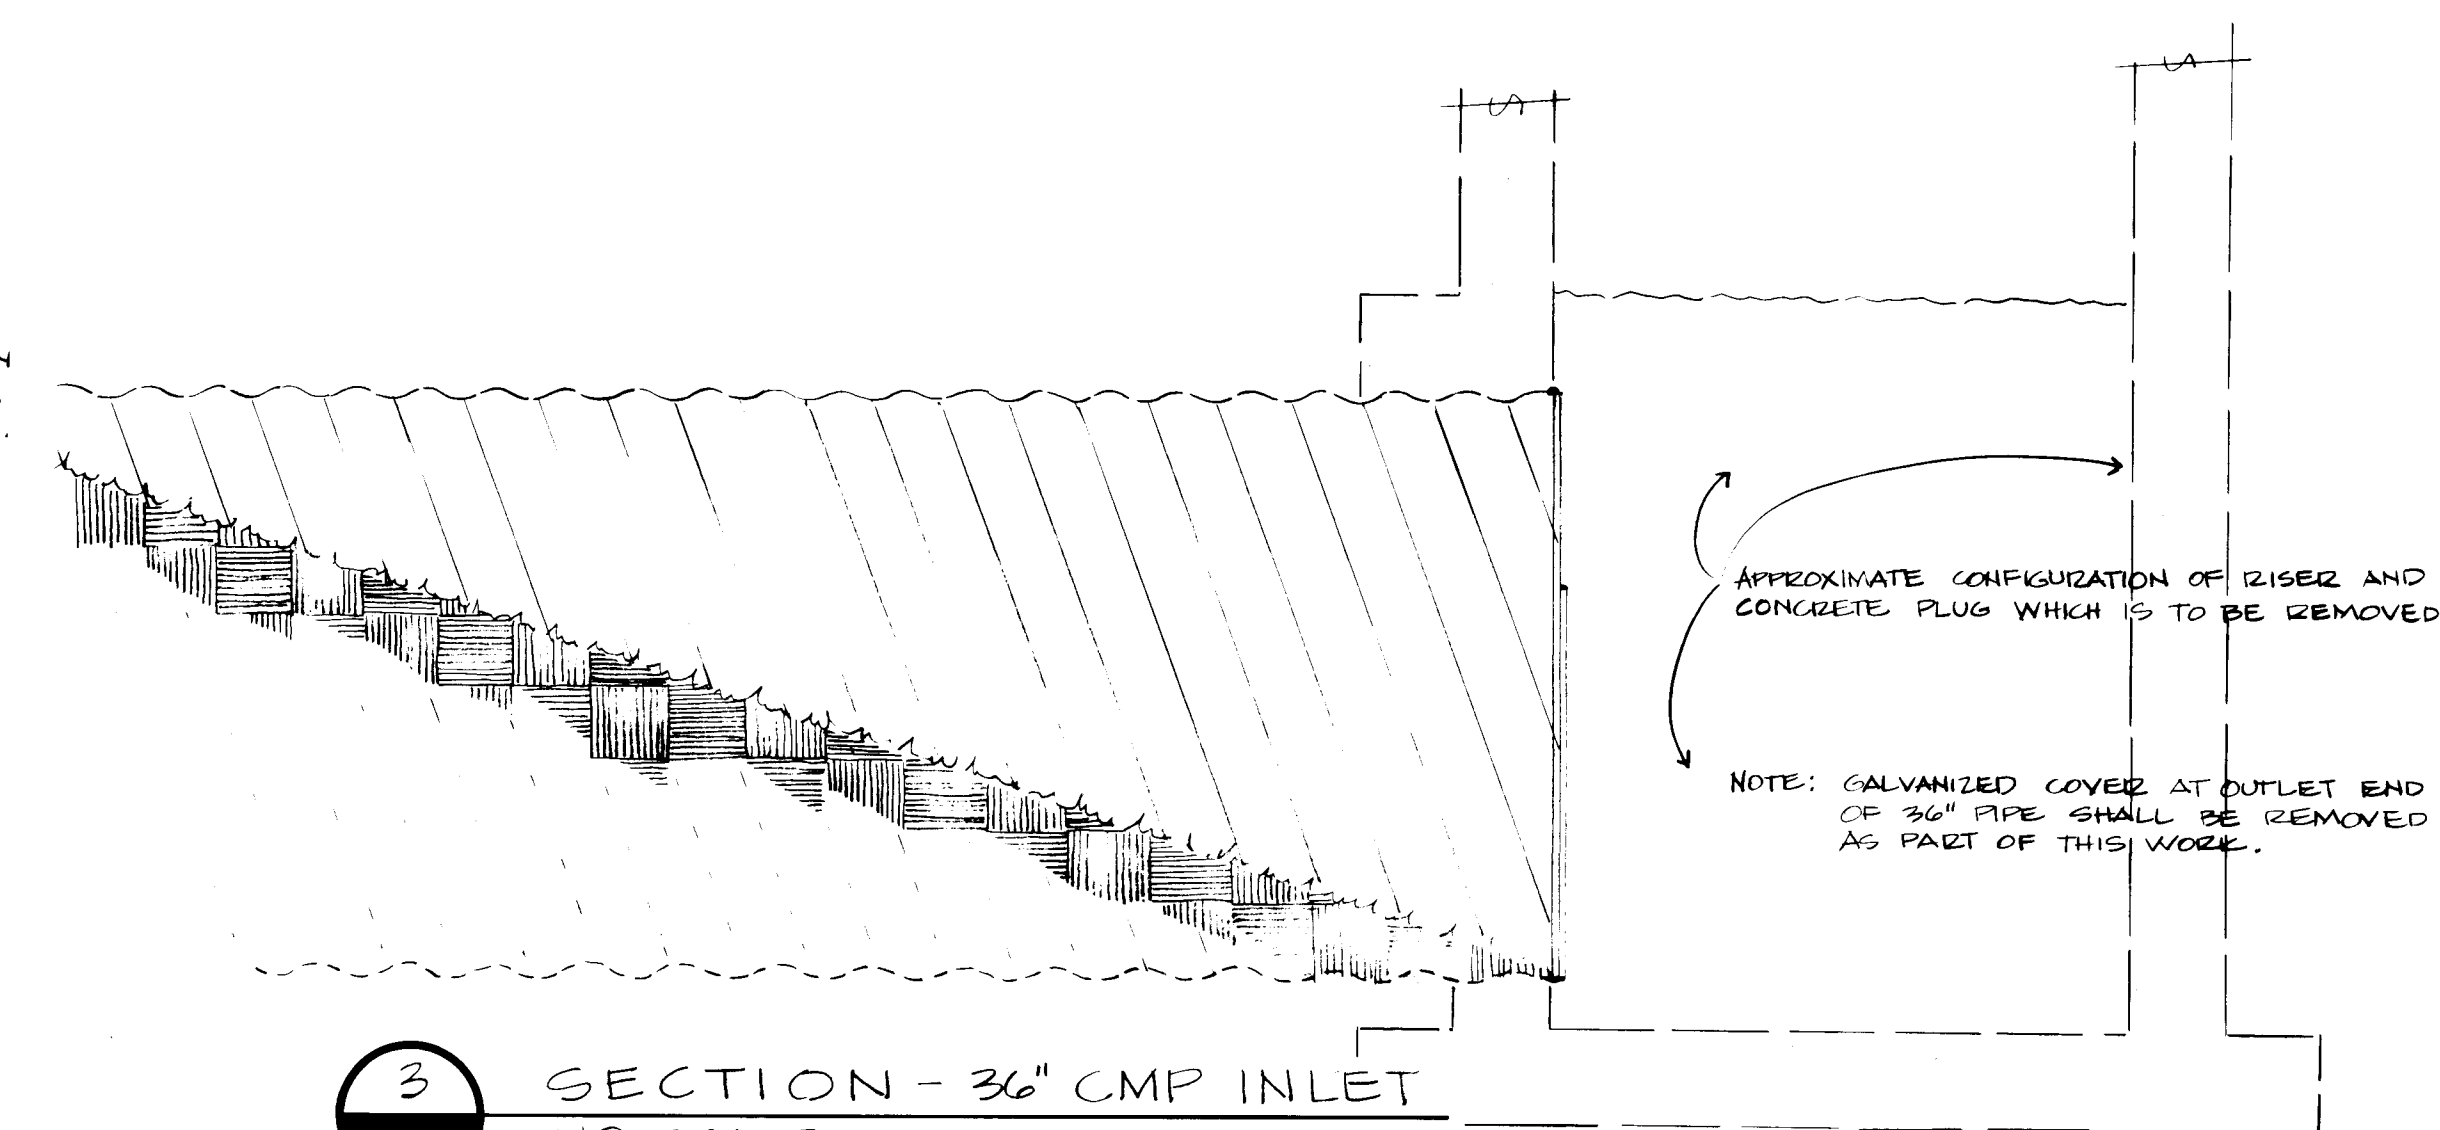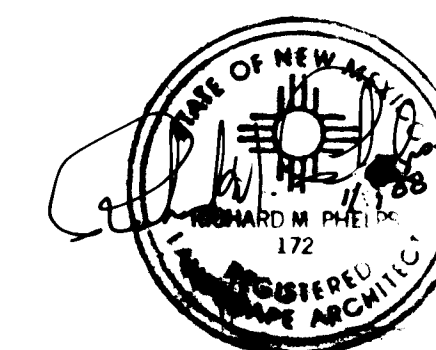

3 SECTION - 36" CMP INLET
NO SCALE

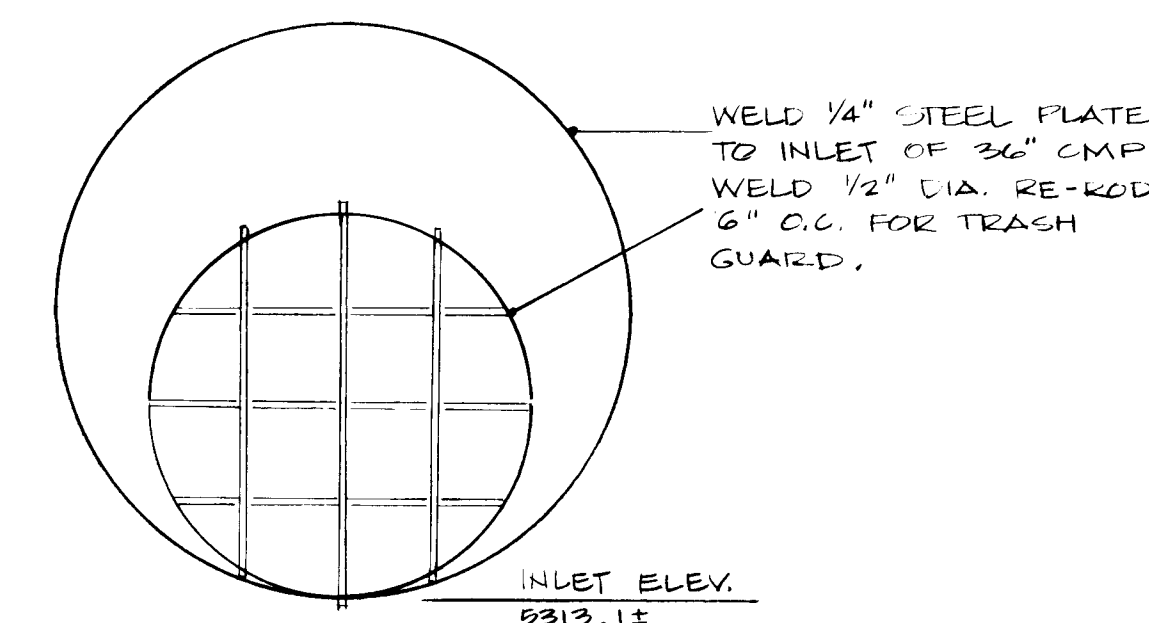

4 INLET WITH 24" 'REDUCER'
NO SCALE


1 2 3 4 5 6 7 8 9 10 11 12
26 34 00 11 90

CITY OF ALBUQUERQUE MUNICIPAL DEVELOPMENT DEPARTMENT ENGINEERING DIVISION					
TITLE: ARROYO DEL OSO GOLF COURSE 9-HOLE ADDITION CONSTRUCTION DETAILS					
APPROVALS	ENGINEER	DATE	APPROVALS	ENGINEER	DATE
City Engineer	<i>[Signature]</i>	1-11-88	Liquid Waste	<i>[Signature]</i>	1/11/88
A.C.E. Design	<i>[Signature]</i>	1-11-88	Traffic	<i>[Signature]</i>	1/11/88
A.C. E-Hydrology	<i>[Signature]</i>	1-8-88	Water	<i>[Signature]</i>	1/8/88
<i>[Signature]</i>	<i>[Signature]</i>	1/7/88			
DRAWING NO.	CD2		MAP NO.	F-19	
			SHEET	11	OF 16

ENGINEER'S SEAL				SURVEY INFORMATION		BENCH MARKS		AS BUILT INFORMATION	
				FIELD NOTES				CONTRACTOR	
				NO.	BY	DATE		WORKS	DATE
								INSPECTED BY	DATE
								ACCEPTANCE BY	DATE
								FIELD VERIFICATION BY	DATE
								DRAWINGS	DATE
								COLLECTED BY	DATE
DESIGN				MICRO-FILM INFORMATION					
				RECORDED BY					
				DATE					
DESIGNED BY								NO.	
DRAWN BY	EP								
CHECKED BY									

	A	B	C	D	E	F	G	H	I	J
CONSTRUCTION @ STA. 22+70	5329.0	5334.0	5336.0	5341.0	5344.06	5340.0	5345.0	5345.0	5335.0	5340.0
CONSTRUCTION @ STA. 27+75	5339.0	5344.0	5346.0	5351.0	5354.06	5350.0	5355.0	5355.0	5345.0	5350.0



DROP STRUCTURE SPOT ELEVATIONS

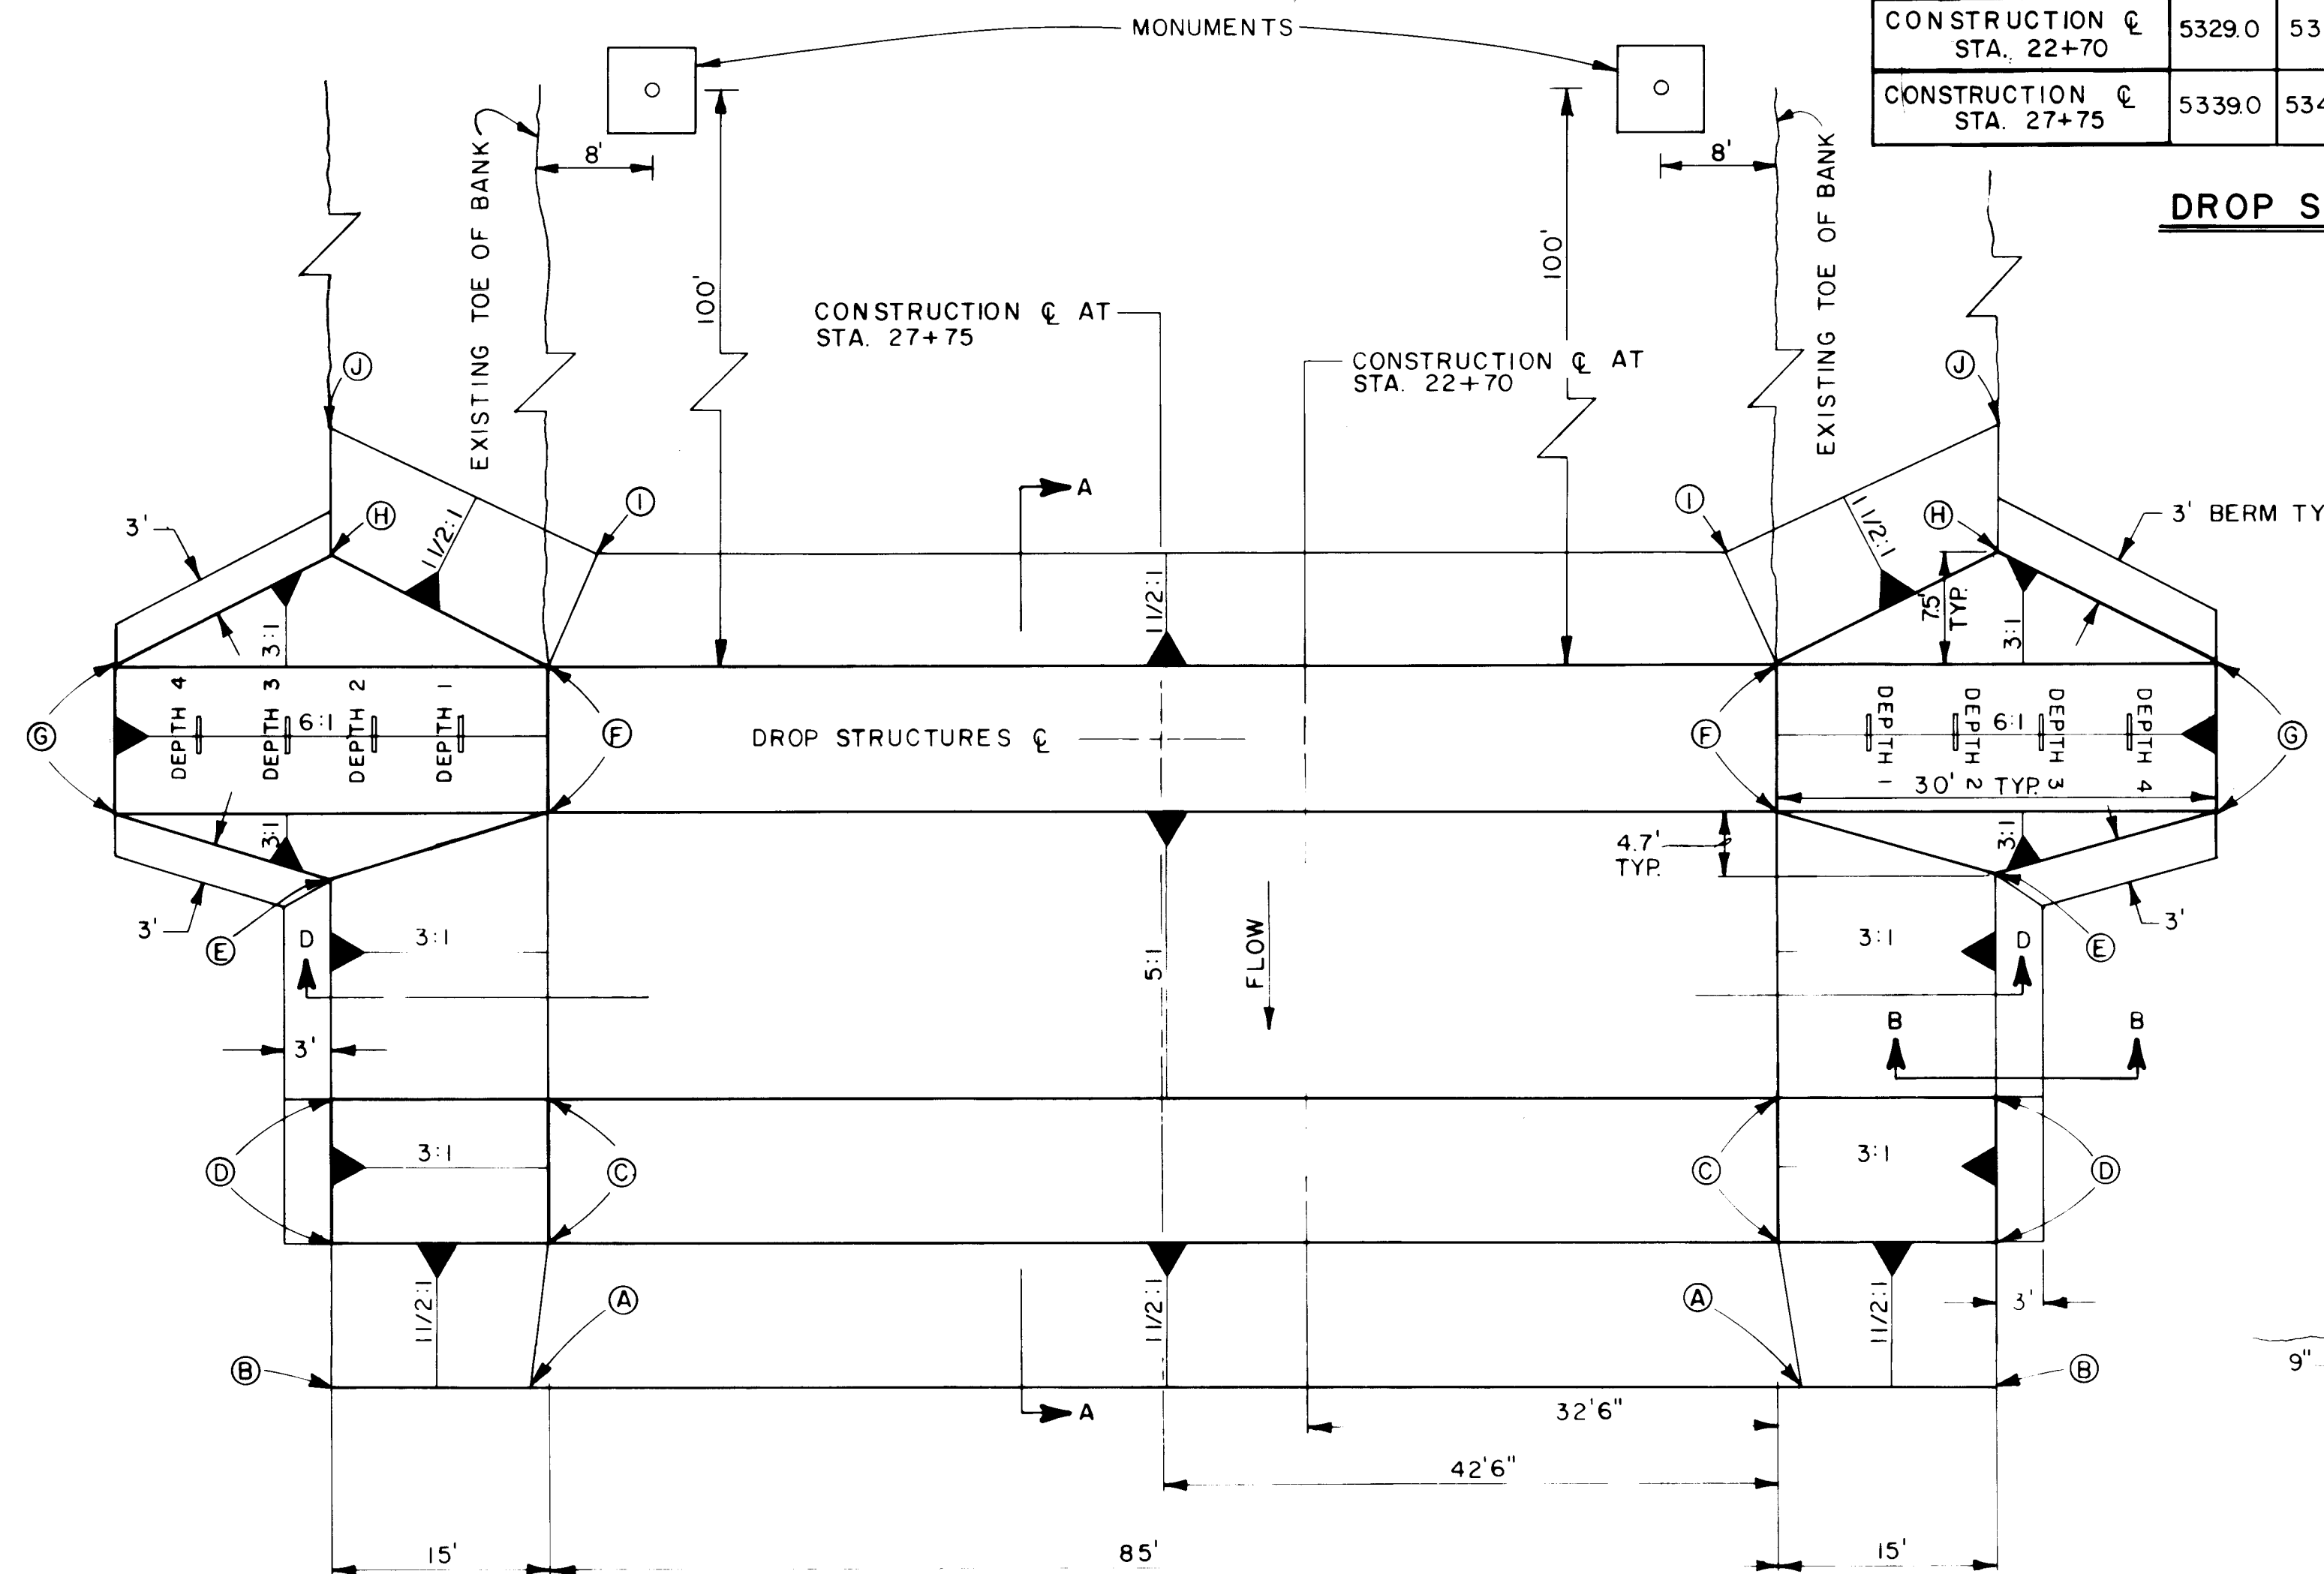

DROP STRUCTURE PLAN


NO SCALE

CHANNEL CONSTRUCTION @ STA. 22+70 &
CHANNEL CONSTRUCTION @ STA. 27+75

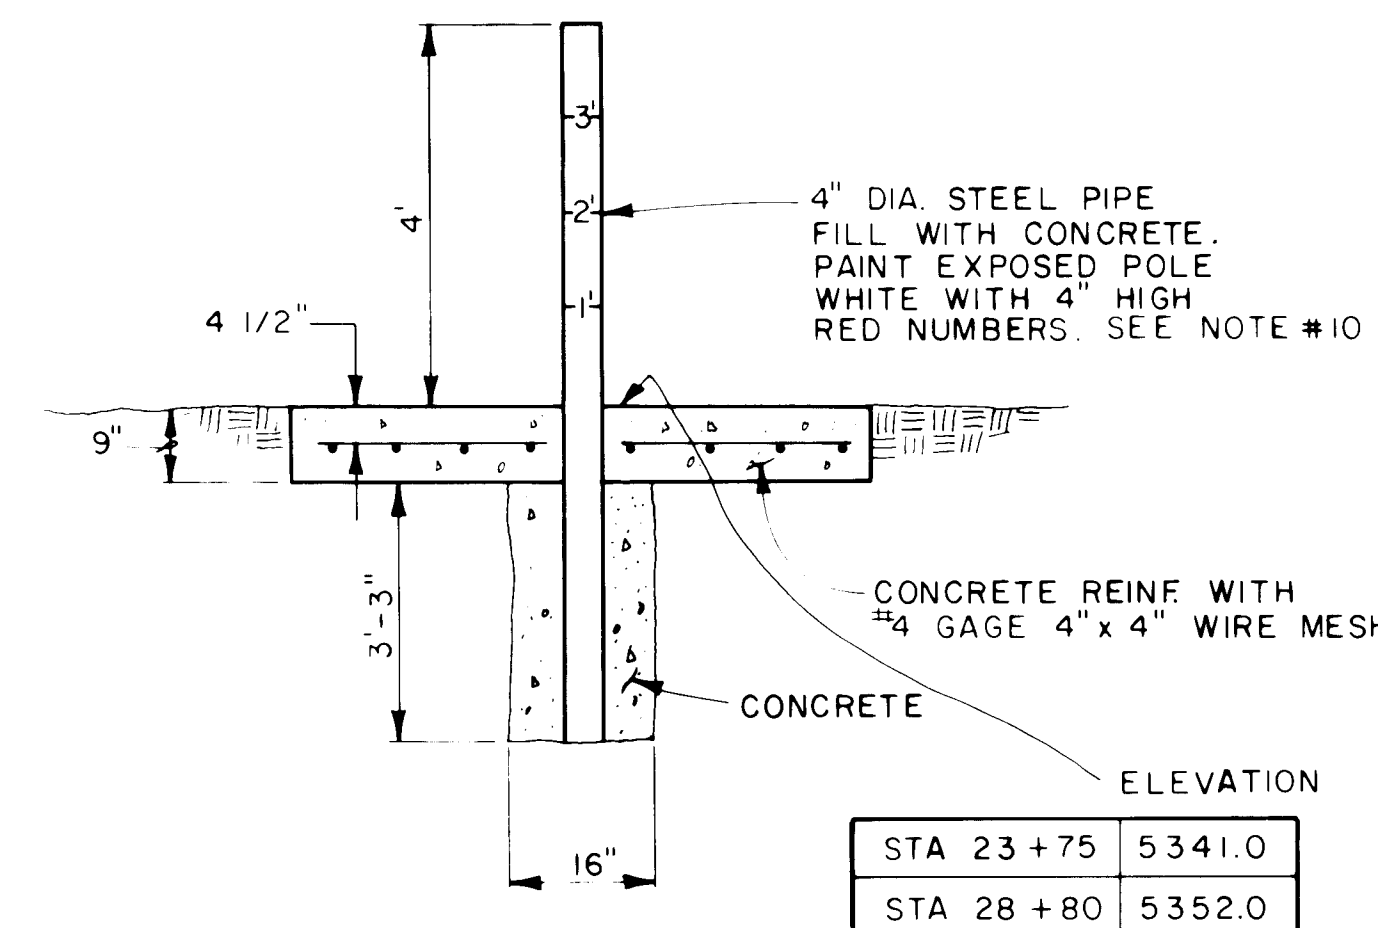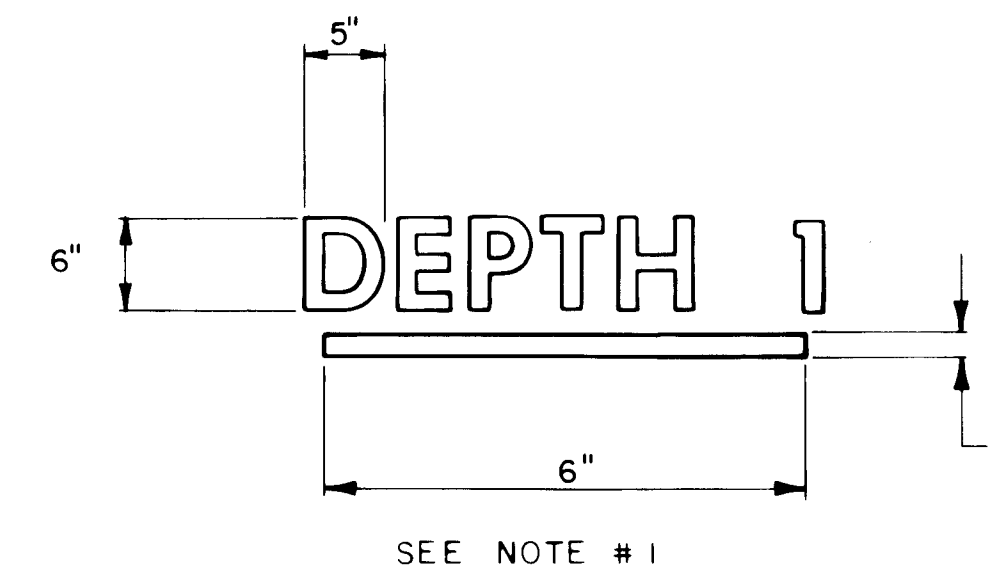


SECTION C-C

NO SCALE

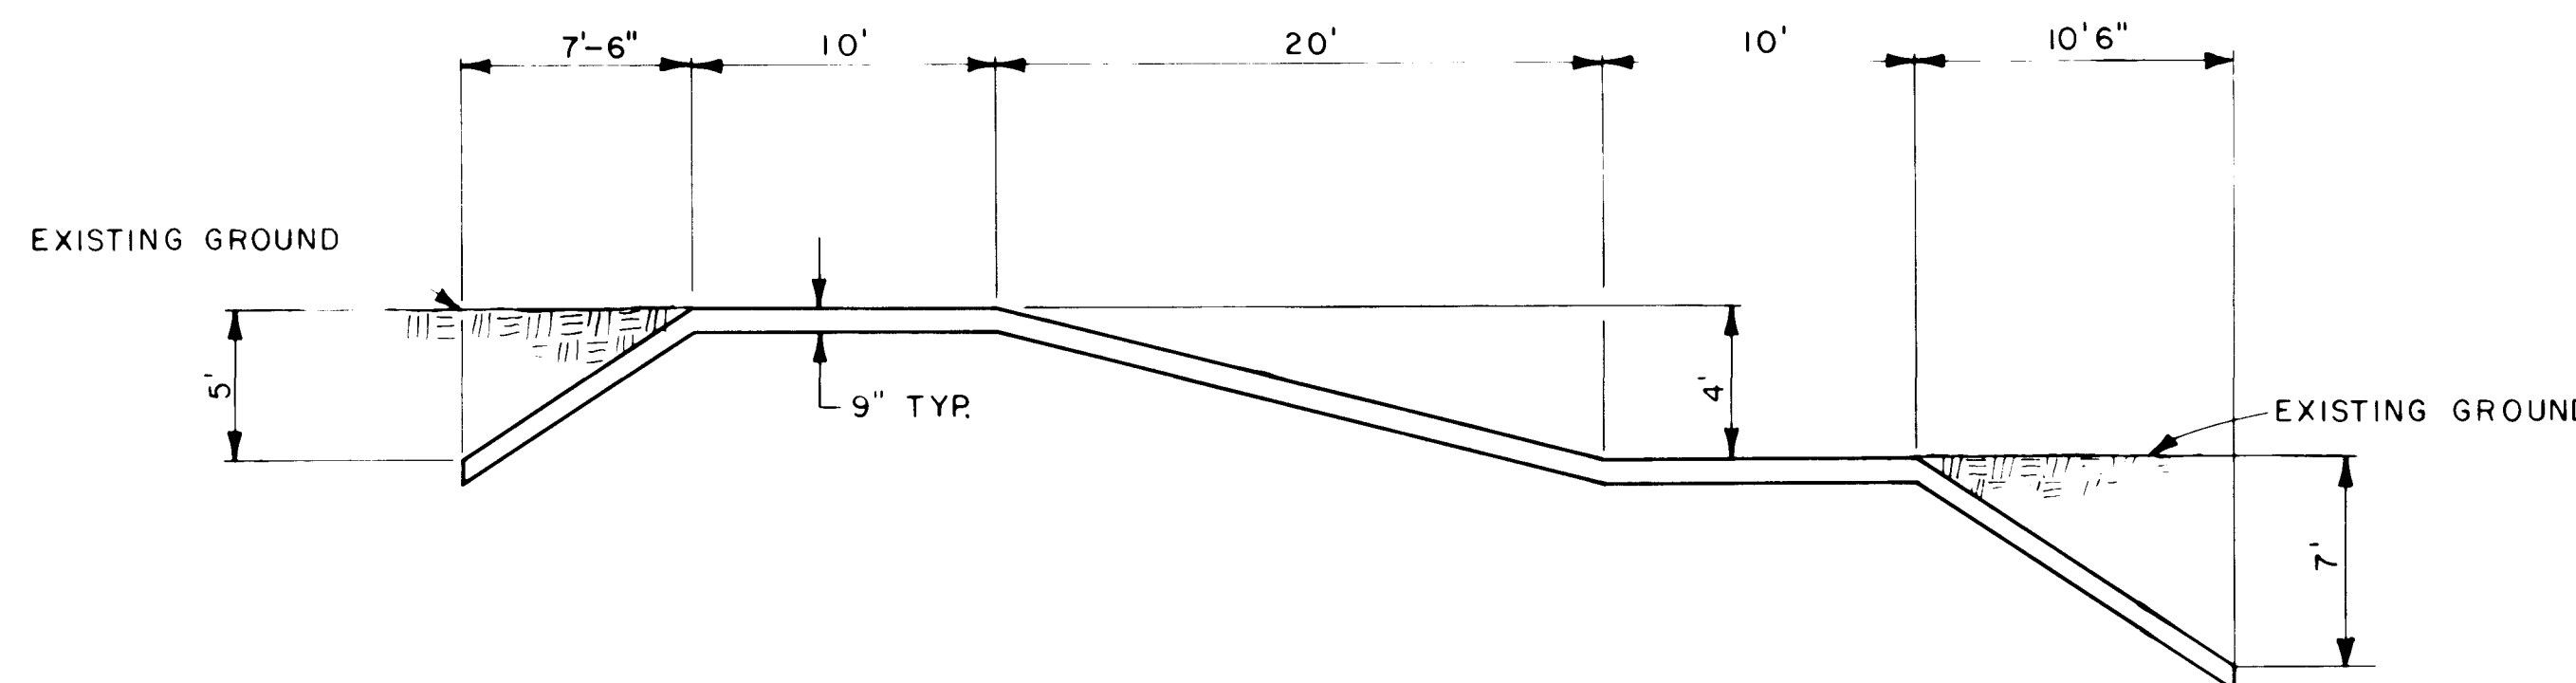


SECTION A-A

NO SCALE

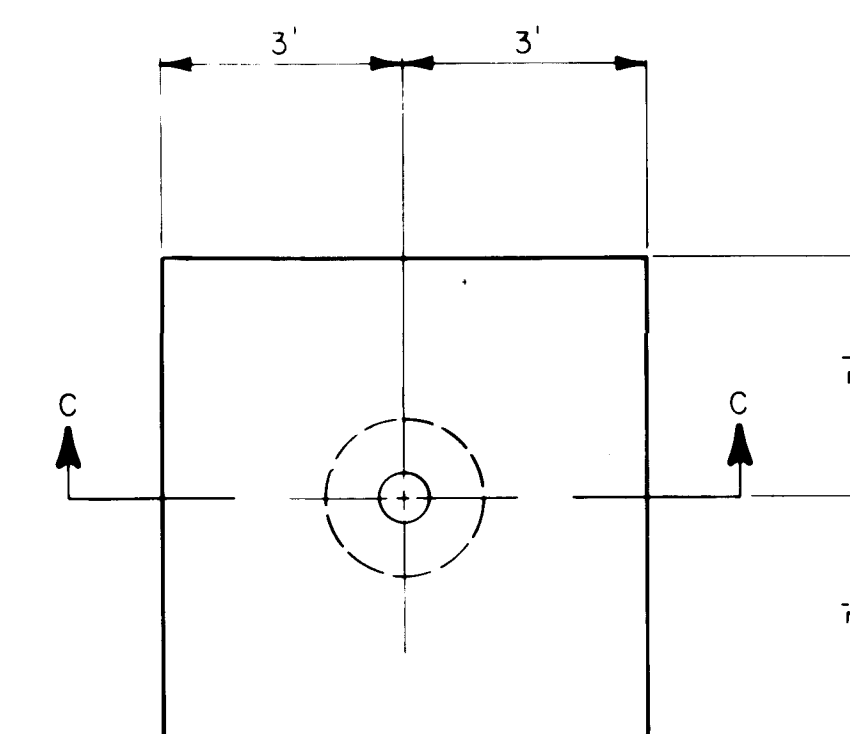


SEDIMENTATION DEPTH MONUMENT

NO SCALE

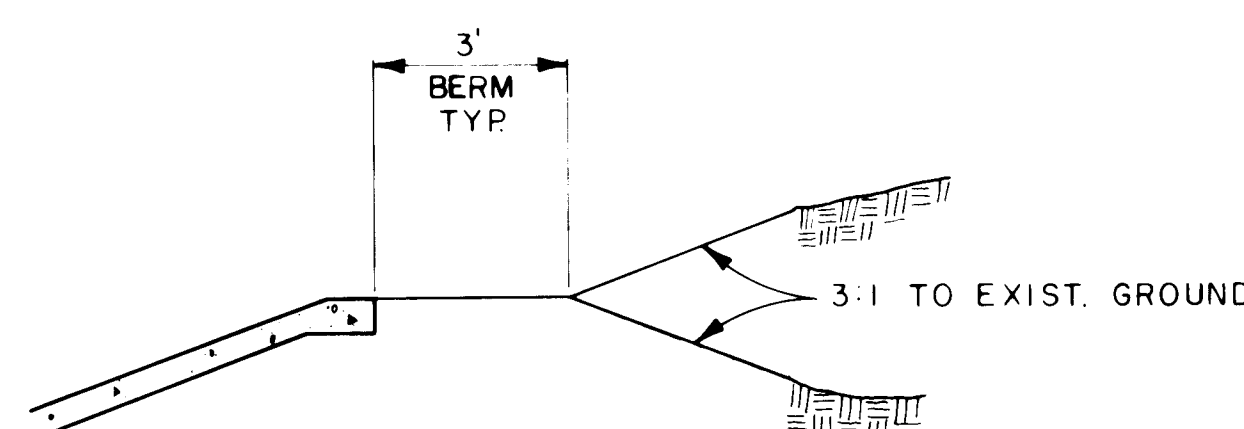

SECTION B-B

NO SCALE

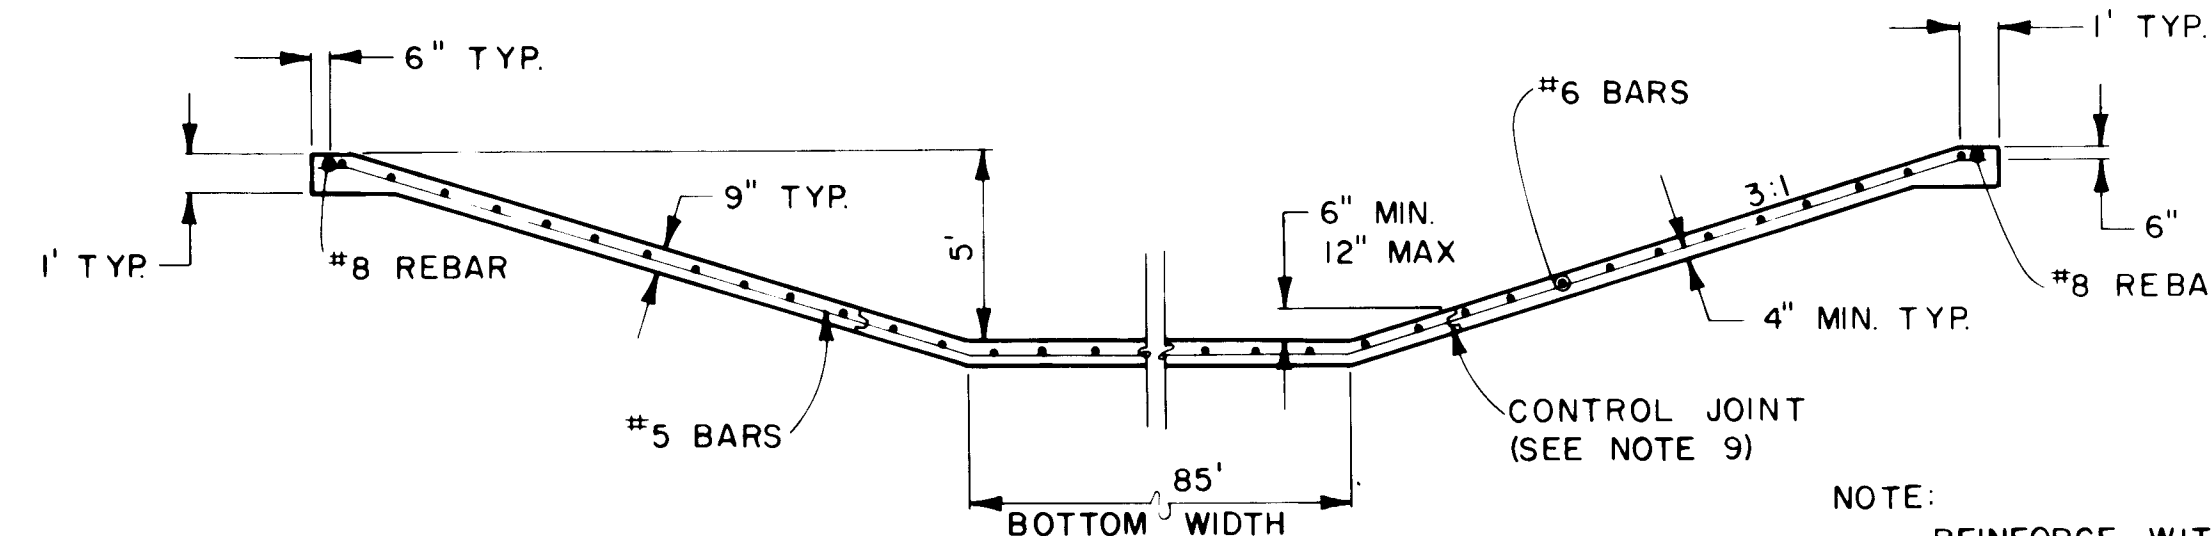

SECTION D-D

NO SCALE

NOTE:
REINFORCE WITH #5 BARS @ 1'-4" O.C. TRANSVERSE & #6 BARS @ 12" O.C. LONGITUDINAL.

CONSTRUCTION NOTES:

- DEPTH MARKERS ON RAMP SHALL BE 6" HIGH LETTERS PAINTED ON A WHITE BACKGROUND. WHITE SHALL BE CONCRETE MASONRY PAINT. RED PAINT SHALL BE ENAMEL.
- CONCRETE SHALL BE 3000 PSI 28 DAY STRENGTH FLYASH WITH MAX. AGGREGATE SIZE AS STATED IN THE SPECIFICATIONS.
- ALL REINFORCING STEEL SHALL BE GRADE 60 DEFORMED BARS, UNLESS OTHERWISE SHOWN.
- SPLICES IN REBAR IN TYPICAL CHANNEL SECTION SHALL BE 1' OR GREATER FOR #3 & #4 BARS, 1'-3" FOR #5 BARS & 2'-9" FOR #6 BARS, UNLESS OTHERWISE SHOWN.
- ALL STEEL SPACING IS GIVEN TO THE CENTERLINE OF THE BARS, UNLESS OTHERWISE SHOWN.
- ALL EXPOSED EDGES SHALL HAVE A 3/4" CHAMFER, UNLESS OTHERWISE SHOWN.
- CHANNEL REBAR SHALL BE SUPPORTED ON 4 1/2" SAND CHAIRS AT A MAX. SPACING OF 5' PERPENDICULAR TO THE CHANNEL CENTERLINE.
- MIN. SUBGRADE COMPACTION SHALL BE 90% PER ASTM D 1557.
- SAW CUT CONTROL JOINT 1/4" WIDE, 2" DEEP & APPLY POLYURETHANE SEALANT OR BURKE COLD KEYED JOINT ENGINEER APPROVED EQUAL. (CONTRACTOR'S OPTION) TYPICAL BOTH SIDES. SEE TYPICAL SECTION.
- MONUMENTS SHALL BE PAINTED WITH ONE COAT OF METAL PRIMER FOLLOWED BY ONE COAT OF WHITE ENAMEL. DEPTH NUMBERS ON MONUMENTS SHALL BE 4" HIGH PAINTED ON TWO SIDES OF MONUMENT WITH RED ENAMEL.
- STRUCTURAL CONCRETE SHALL BE TINTED WITH DAVIS COLOR (OR EQUIVALENT) 5447 BUFF AS REQUIRED BY THE SPECIFICATIONS.
- ENGINEER SHALL APPROVE HORIZONTAL LOCATION OF DROP STRUCTURES BEFORE CONSTRUCTION.

26 3400 1290




CITY OF ALBUQUERQUE
ARROYO DEL OSO
GOLF COURSE EXPANSION

TITLE: CONCRETE DROP STRUCTURES CONSTRUCTION DETAILS

APPROVALS	ENGINEER	DATE	APPROVALS	ENGINEER	DATE
City Engineer	<i>[Signature]</i>	11-18-87	Liquid Waste	<i>[Signature]</i>	11/18/87
A C E - Design	<i>[Signature]</i>	11-18-87	Traffic	<i>[Signature]</i>	11/18/87
A C E - Hydrology	<i>[Signature]</i>	11-18-87	Water	<i>[Signature]</i>	11/18/87
DESIGNED BY	BG	DATE OCT., 1987	CHECKED BY	HCS	DATE OCT., 1987
DRAWN BY	VCG	DATE OCT., 1987			

DRAWING NO. **CD-3** MAP NO. **F-19** SHEET **12** OF **16**

BOHANNAN-HUSTON INC. JOB NO. 86430.04

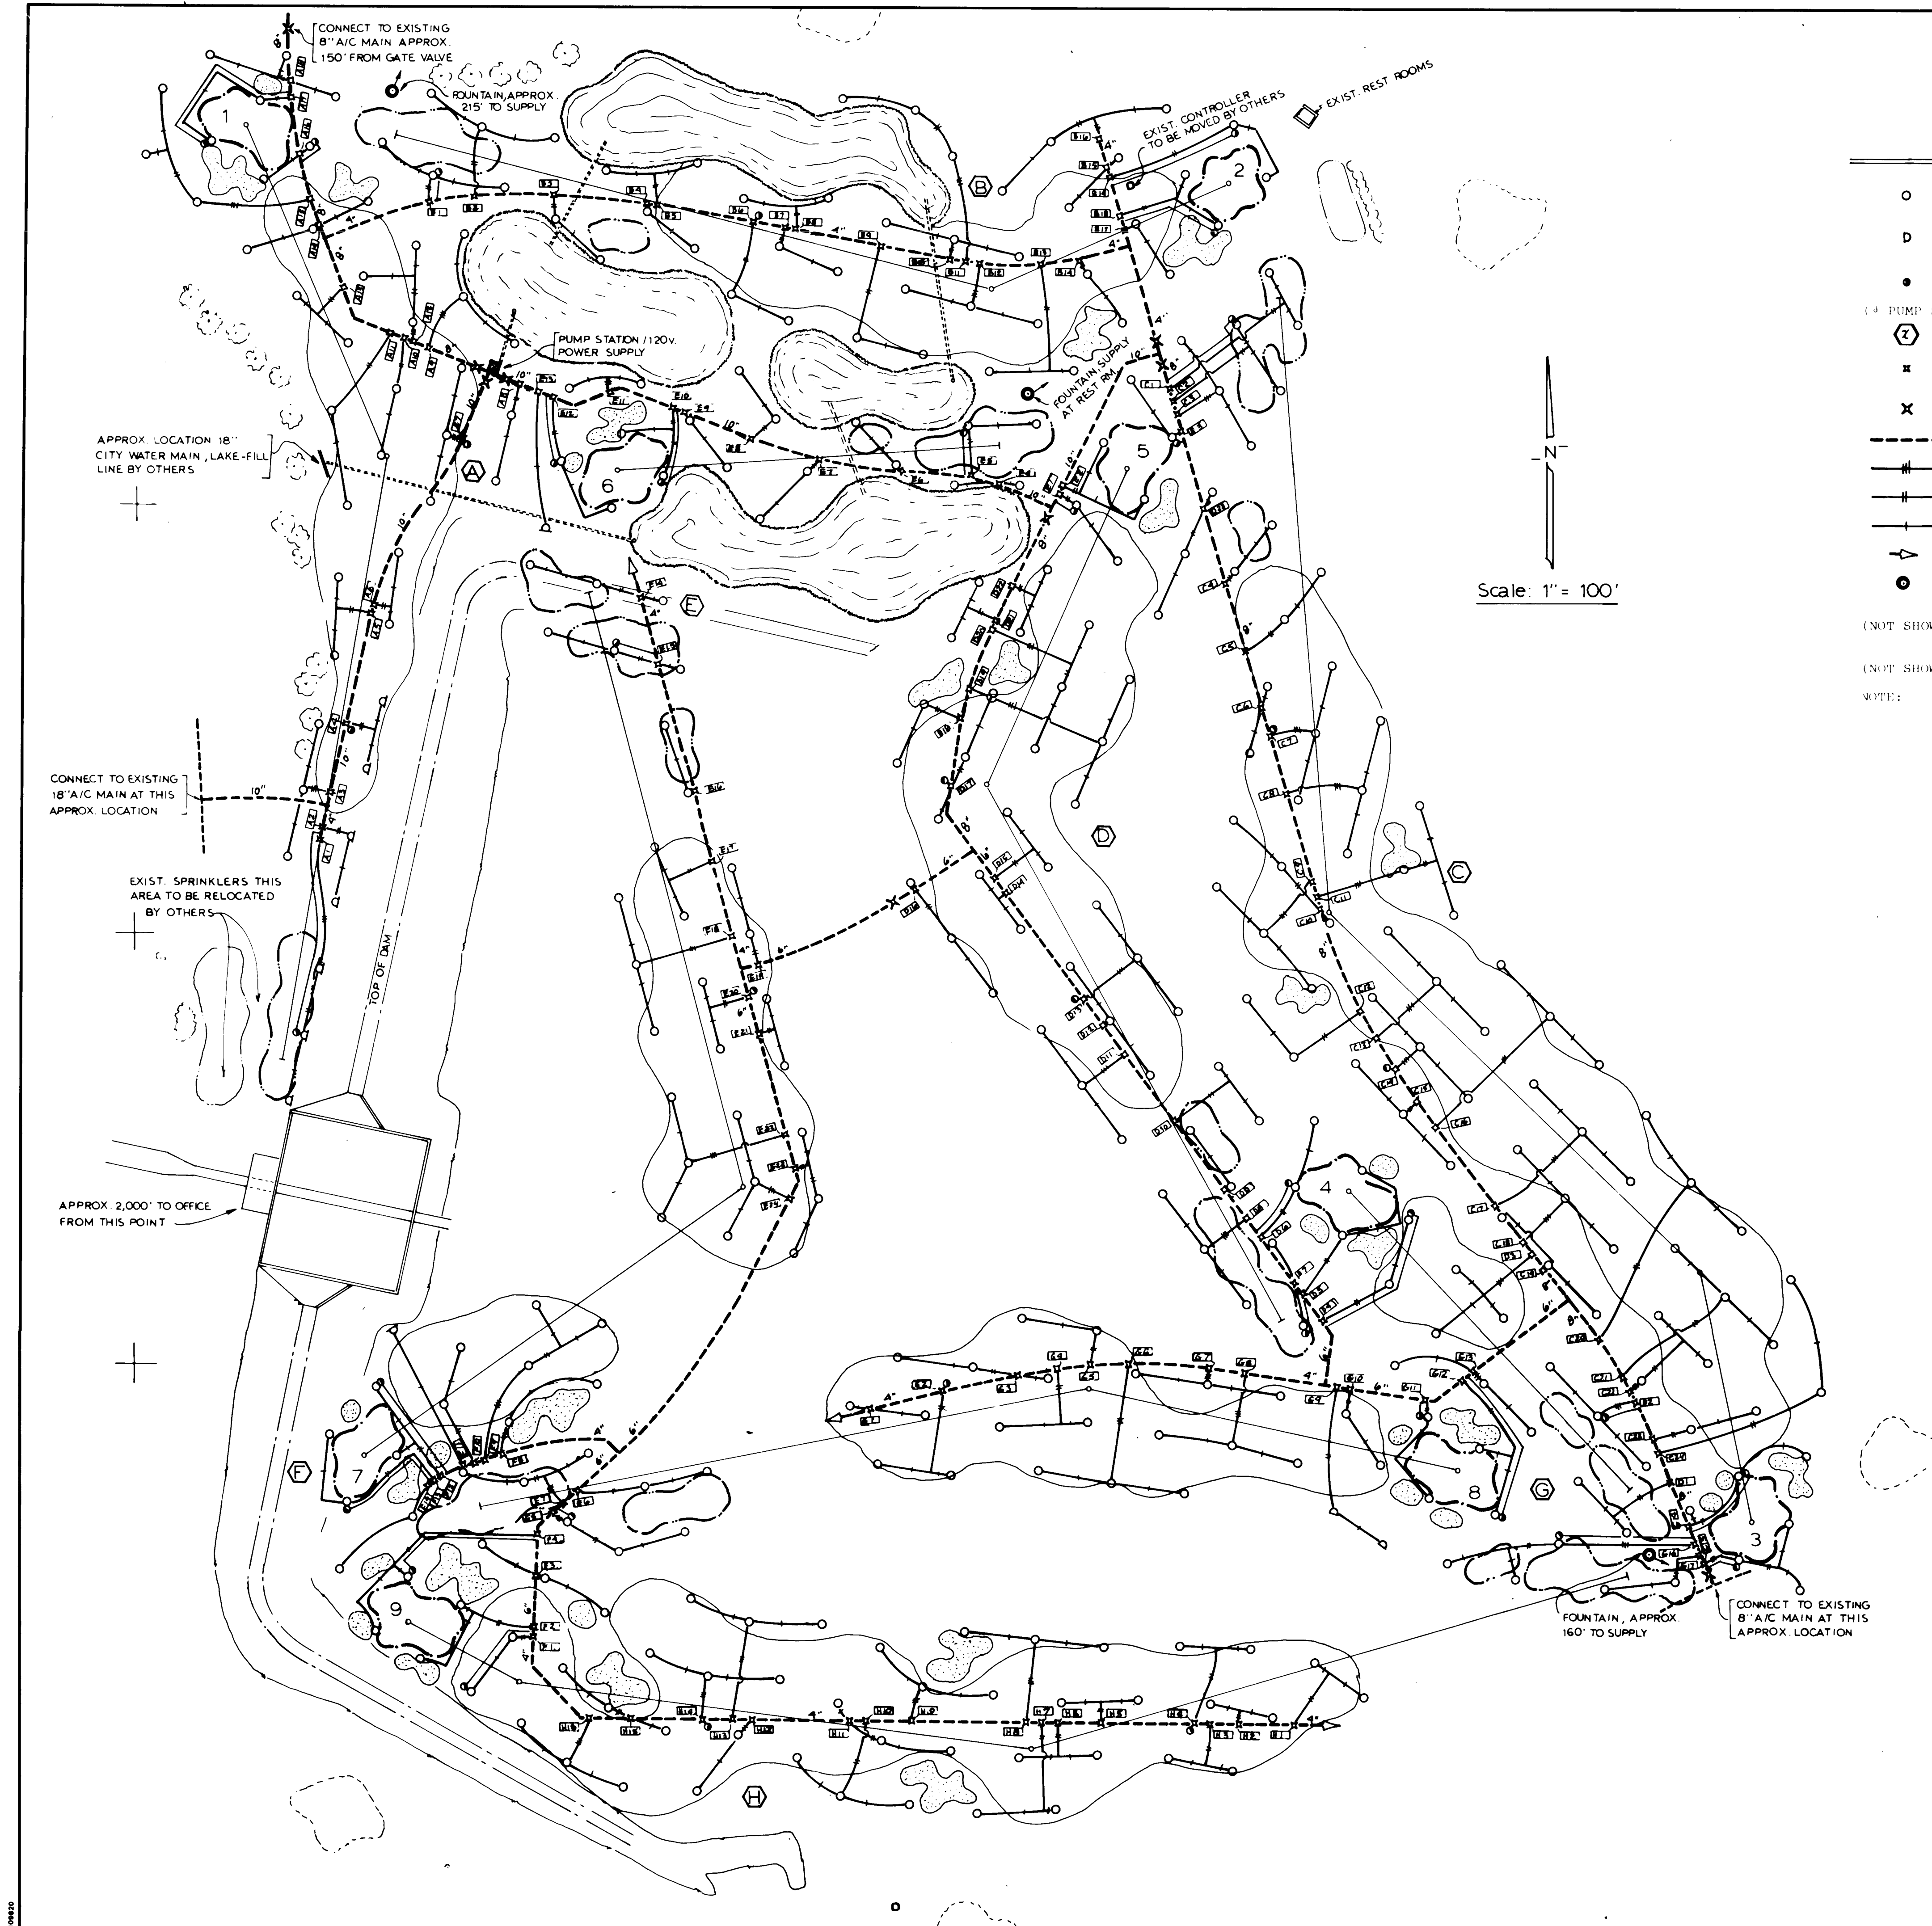

LEGEND and NOTES

- O TORO MODEL 674-02-71 FULL-CIRCLE SPRINKLER W/CHECK VALVE -- 45.6 GPM 85' R @ 80 PSI
- D TORO MODEL 655-02-58 PART-CIRCLE SPRINKLER W/CHECK VALVE -- 37.2 GPM 77' R @ 80 PSI
- TORO MODEL 474-00 1" QUICK-COUPLING VALVE - USE 1 1/4" CLASS 200 PVC ML TO QCV
- (PUMP STA) TO PAZ MODEL 53493-00Q3 LINE 1 POWER CONDITIONER
- ⊗ TORO MODEL 132-56-08 NETWORK 8000 SATELLITE CONTROLLER
- ⊠ TORO MODEL 216-27-08 2" ELECTRIC, PRESSURE REGULATING REMOTE CONTROL VALVE
- X LINE SIZE GATE VALVE
- CLASS 200 RUBBER-RING-JOINT PVC MAINLINE (SIZE AS SHOWN)
- 3" CLASS 200 SOLVENT-WELD PVC LATERAL
- 2 1/2" " " " " " "
- 2" " " " " " "
- ▽ AIR RELIEF AND FLUSH VALVE
- LOCATION OF DRINKING FOUNTAIN. INSTALL 1" PVC WATER LINE, FOUNTAIN BY OTHERS.

(NOT SHOWN) 120 VOLT POWER WIRE FROM SOURCE TO ALL SATELLITES SHALL BE NO. 6 UF COPPER

(NOT SHOWN) 24 VOLT CONTROL AND COMMON WIRE SHALL BE NO. 14 UF COPPER

NOTE: SEE SHEET 1-2 FOR LAKE FILL LINE DETAIL. MANUFACTURER'S NAMES AND MODEL NUMBERS ARE USED TO ESTABLISH QUALITY AND PERFORMANCE REQUIRED, AND IS NOT INTENDED TO LIMIT USE OF MATERIALS OF EQUAL QUALITY AND PERFORMANCE. SEE SPECIFICATIONS FOR FURTHER INFORMATION.

SATELLITE	VALVES	SPRINKLERS
(A)	18	44
(B)	19	44
(C)	24	63
(D)	23	57
(E)	24	53
(F)	14	31
(G)	17	42
(H)	16	40
8	155	374

SUGGESTED IRRIGATION SCHEDULE

SET AVERAGE TIME ON SPRINKLER ZONES TO 5 MINUTES.

FOR PEAK DEMAND SET DAILY SCHEDULE AS FOLLOWS:

START ALL SATELLITES AT 9:30 PM

REPEAT STARTS -- 11:30 PM
1:30 AM
AND 3:30 AM

FOR A TOTAL APPLICATION OF 0.264 INCHES

ADD OR DELETE IRRIGATION CYCLES AS DEMAND CHANGES.

AVERAGE DEMAND = 875 GPM

AVERAGE DAILY PEAK CONSUMPTION = APPROXIMATELY 342,000 GALLONS


AS BUILT INFORMATION		BENCH MARKS		SURVEY INFORMATION		ENGINEER'S SEAL	
CONTRACTOR	WORK	DATE	NO.	BY	DATE	NO.	BY
STAMPED BY	DATE	DATE	DATE	DATE	DATE	DATE	DATE
ACCEPTANCE BY	DATE	DATE	DATE	DATE	DATE	DATE	DATE
FIELD LOCATION BY	DATE	DATE	DATE	DATE	DATE	DATE	DATE
DRAWINGS	DATE	DATE	DATE	DATE	DATE	DATE	DATE
CORRECTED BY	DATE	DATE	DATE	DATE	DATE	DATE	DATE
RECORDED BY	DATE	DATE	DATE	DATE	DATE	DATE	DATE
NO	NO	NO	NO	NO	NO	NO	NO

REVISIONS		DESIGN	
NO.	DATE	REMARKS	BY
1	11-11-87	DESIGN	E. Lozano
2	1-8-88	DESIGN	E. Lozano
3	1-11-88	DESIGN	E. Lozano
4	1-11-88	DESIGN	E. Lozano
5	1-11-88	DESIGN	E. Lozano
6	1-11-88	DESIGN	E. Lozano
7	1-11-88	DESIGN	E. Lozano
8	1-11-88	DESIGN	E. Lozano
9	1-11-88	DESIGN	E. Lozano
10	1-11-88	DESIGN	E. Lozano
11	1-11-88	DESIGN	E. Lozano
12	1-11-88	DESIGN	E. Lozano

DESIGNED BY	E. Lozano	DATE	Dec 1987
DRAWN BY		DATE	
CHECKED BY		DATE	

26 34001390

CITY OF ALBUQUERQUE MUNICIPAL DEVELOPMENT DEPARTMENT ENGINEERING DIVISION					
TITLE: ARROYO DEL OSO GOLF COURSE SPRINKLER SYSTEM					
APPROVALS	ENGINEER	DATE	APPROVALS	ENGINEER	DATE
City Engineer	Robert H. Hays	1-11-87	Liquid Waste	REDO	1/6/88
A.C.E. Design	W. H. Hays	1-11-87	Traffic	PC	1/11/87
A.C.E. Hydrology	W. H. Hays	1-8-88	Water	REDO	1/8/88
PAZ	W. H. Hays	1/7/88			
DRAWING NO.	I-1	MAP NO.	F19	SHEET	13 OF 16

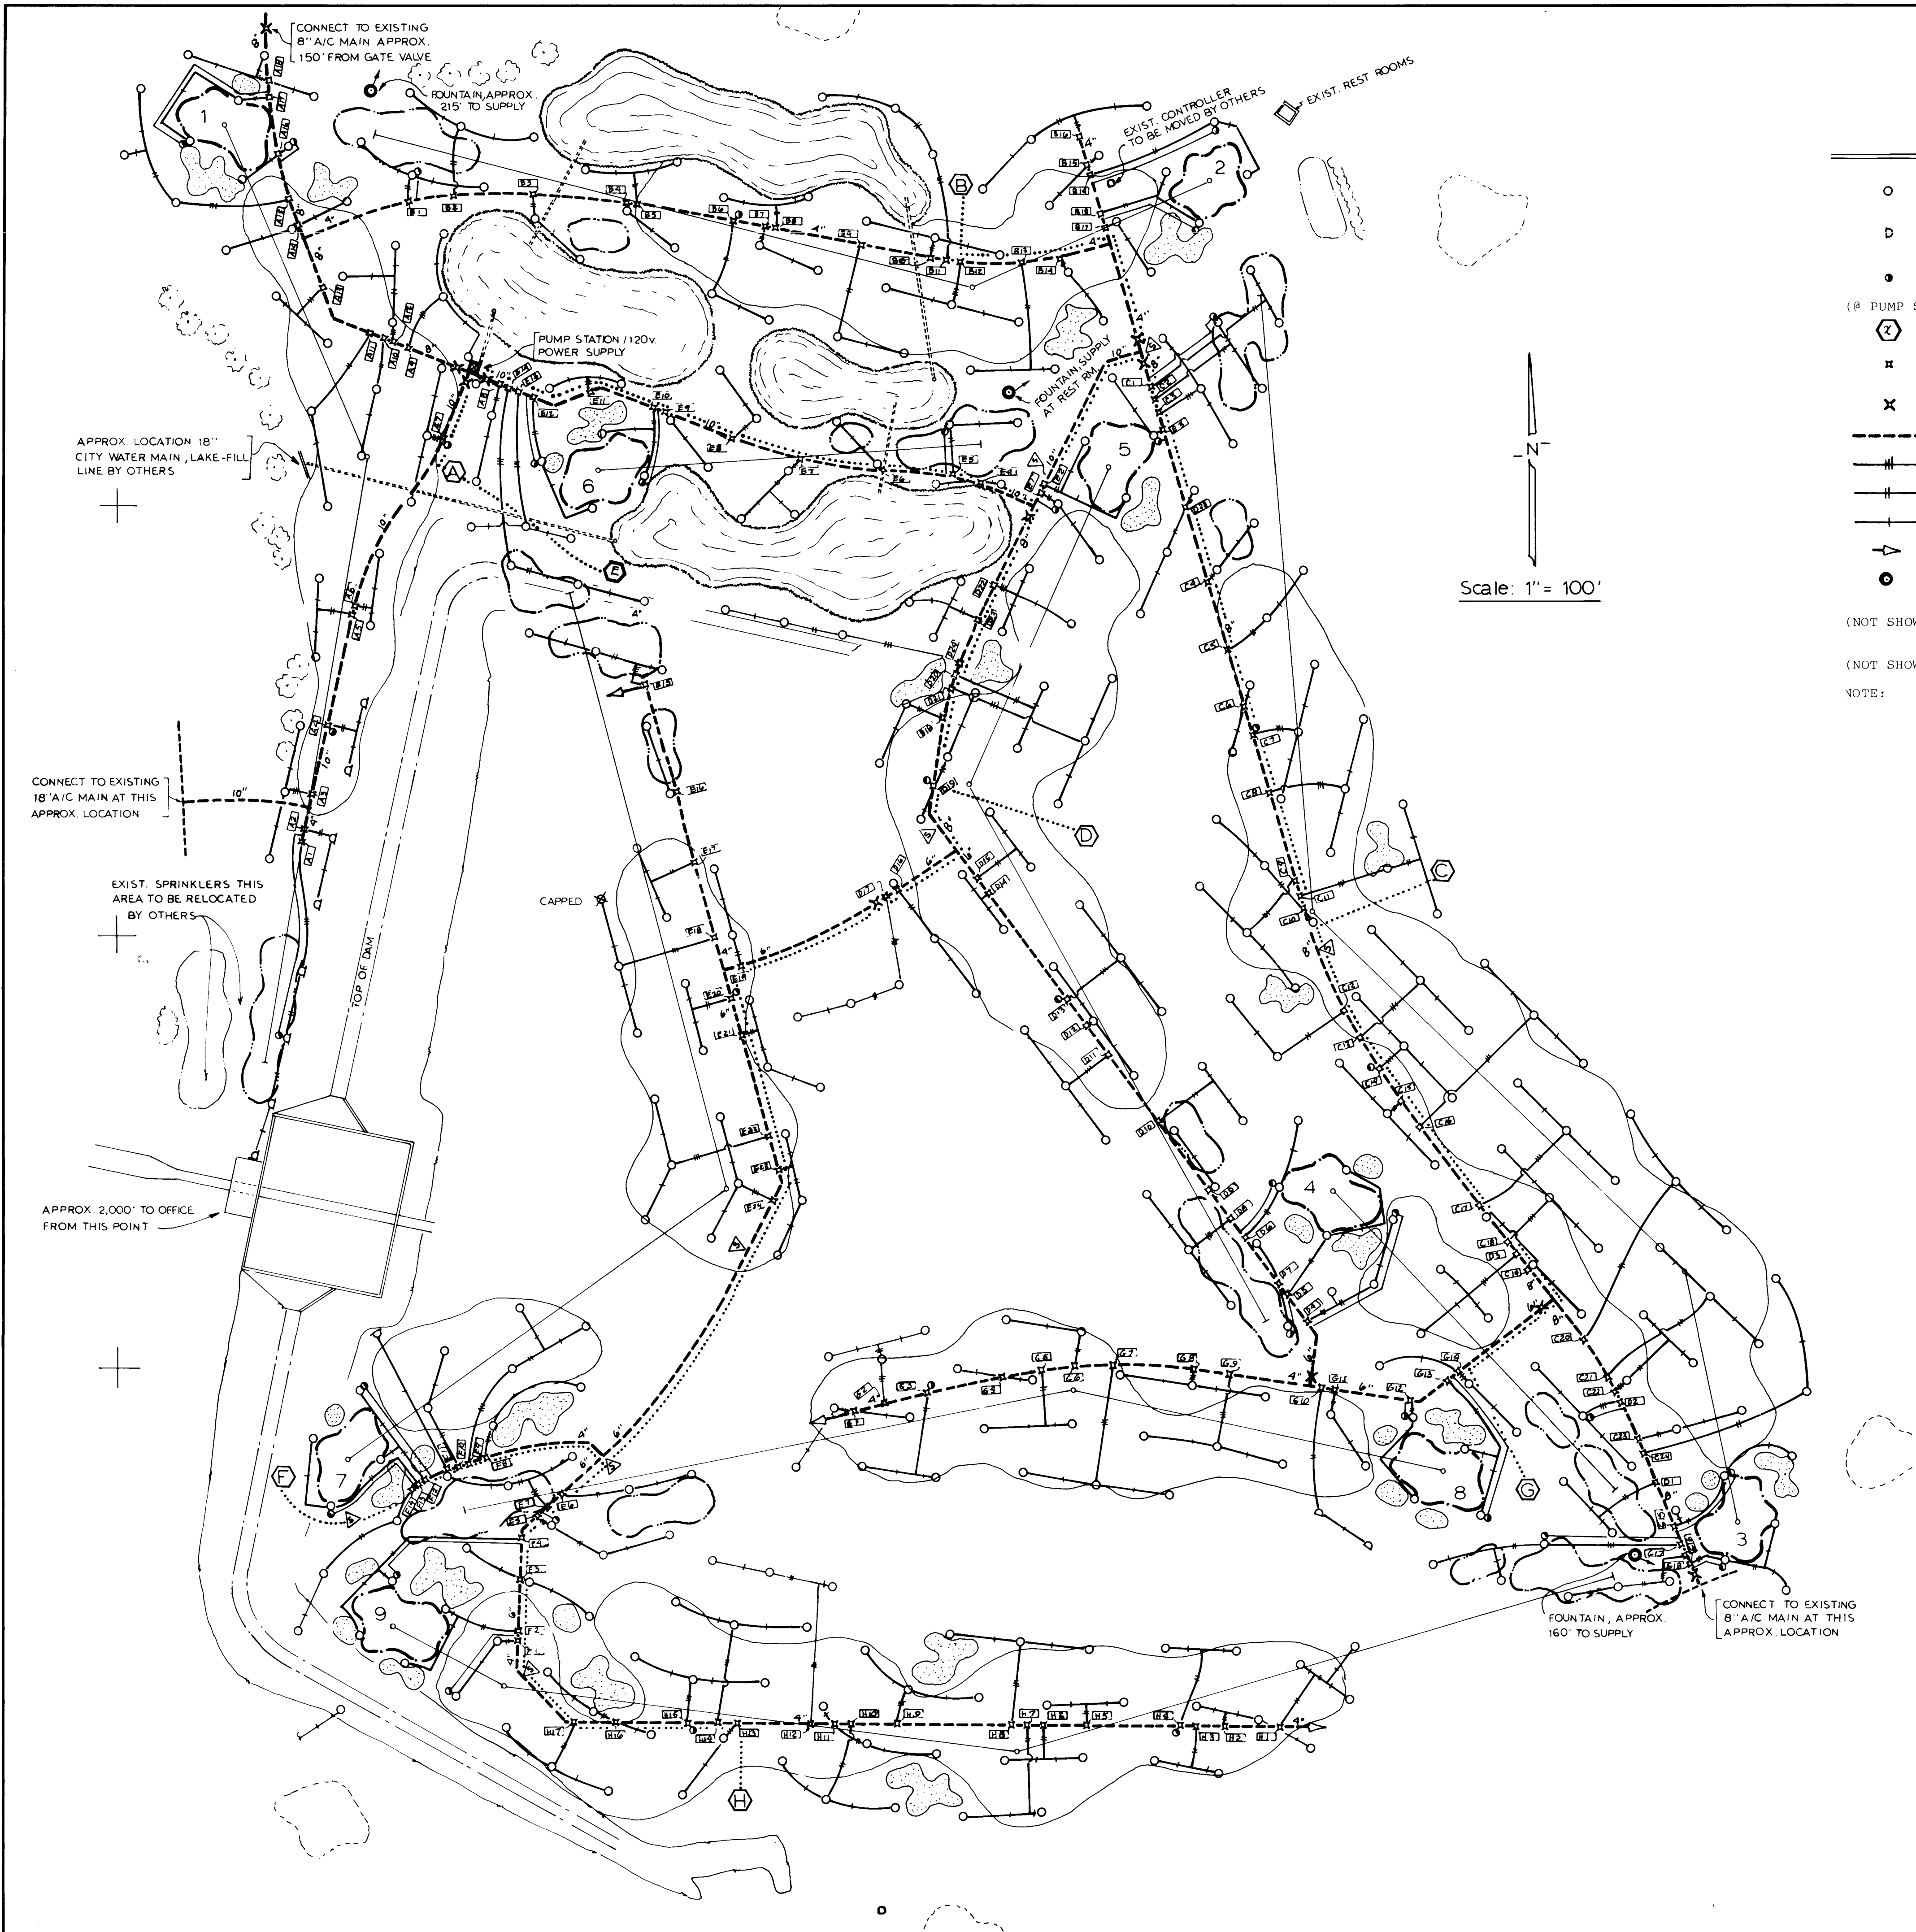

LEGEND and NOTES

- O TORO MODEL 674-02-71 FULL-CIRCLE SPRINKLER W/CHECK VALVE -- 45.6 GPM 85' R @ 80 PSI
- D TORO MODEL 655-02-58 PART-CIRCLE SPRINKLER W/CHECK VALVE -- 37.2 GPM 77' R @ 80 PSI
- TORO MODEL 474-00 1" QUICK-COUPLING VALVE - USE 1 1/4" CLASS 200 PVC M.L. TO GCV
- (@ PUMP STA) TOPAZ MODEL 53493-00Q3 LINE 1 POWER CONDITIONER
- ⓧ TORO MODEL 132-56-08 NETWORK 8000 SATELLITE CONTROLLER
- ⌘ TORO MODEL 216-27-08 2" ELECTRIC, PRESSURE REGULATING REMOTE CONTROL VALVE
- X LINE SIZE GATE VALVE
- CLASS 200 RUBBER-RING-JOINT PVC MAINLINE (SIZE AS SHOWN)
- 3" CLASS 200 SOLVENT-WELD PVC LATERAL
- 2 1/2" " " " " " "
- 2" " " " " " "
- ⤴ AIR RELIEF AND FLUSH VALVE ⚡ ELECTRICAL SPLICE BOX 120V POWER TO CONTROLLERS
- LOCATION OF DRINKING FOUNTAIN. INSTALL 1" PVC WATER LINE, FOUNTAIN BY OTHERS.

(NOT SHOWN) 120 VOLT POWER WIRE FROM SOURCE TO ALL SATELLITES SHALL BE NO. 6 UF COPPER

(NOT SHOWN) 24 VOLT CONTROL AND COMMON WIRE SHALL BE NO. 14 UF COPPER

NOTE: SEE SHEET I-11 FOR LAKE FILL LINE DETAIL. MANUFACTURER'S NAMES AND MODEL NUMBERS ARE USED TO ESTABLISH QUALITY AND PERFORMANCE REQUIRED, AND IS NOT INTENDED TO LIMIT USE OF MATERIALS OF EQUAL QUALITY AND PERFORMANCE. SEE SPECIFICATIONS FOR FURTHER INFORMATION.

SATELLITE	VALVES	SPRINKLERS
(A)	18	46
(B)	19	44
(C)	24	64
(D)	24	62
(E)	24	56
(F)	14	32
(G)	18	46
(H)	17	45
8	158	395

SUGGESTED IRRIGATION SCHEDULE

SET AVERAGE TIME ON SPRINKLER ZONES TO 5 MINUTES.
FOR PEAK DEMAND SET DAILY SCHEDULE AS FOLLOWS:

START ALL SATELLITES AT 9:30 PM
REPEAT STARTS -- 11:30 PM
1:30 AM
AND 3:30 AM


FOR A TOTAL APPLICATION OF 0.264 INCHES
ADD OR DELETE IRRIGATION CYCLES AS DEMAND CHANGES.
AVERAGE DEMAND = 875 GPM
AVERAGE DAILY PEAK CONSUMPTION = APPROXIMATELY 342,000 GALLONS

AS BUILT PLAN NOV. 1988
E. Lee Bean IRRIGATION ENGINEERING
105 W 32nd St BOISE, ID 83704 (208) 384 0510

26 340013904



CITY OF ALBUQUERQUE MUNICIPAL DEVELOPMENT DEPARTMENT ENGINEERING DIVISION					
TITLE: ARROYO DEL OSO GOLF COURSE SPRINKLER SYSTEM					
APPROVALS	ENGINEER	DATE	APPROVALS	ENGINEER	DATE
City Engineer			Liquid Waste		
A.C.E. Design			Traffic		
A.C. E. Hydrology			Water		
DRAWING NO. I-1		MAP NO. F19		SHEET 13 OF 16	

AS BUILT INFORMATION		BENCH MARKS		SURVEY INFORMATION		ENGINEER'S SEAL	
CONTRACTOR	DATE	NO.	DATE	NO.	DATE	NO.	DATE
WORK	DATE	BY	DATE	BY	DATE	BY	DATE
DESIGNED BY	DATE	DESIGNED BY	DATE	DESIGNED BY	DATE	DESIGNED BY	DATE
ACCEPTANCE BY	DATE	ACCEPTANCE BY	DATE	ACCEPTANCE BY	DATE	ACCEPTANCE BY	DATE
VERIFICATION BY	DATE	VERIFICATION BY	DATE	VERIFICATION BY	DATE	VERIFICATION BY	DATE
DRAWINGS	DATE	DRAWINGS	DATE	DRAWINGS	DATE	DRAWINGS	DATE
CORRECTED BY	DATE	CORRECTED BY	DATE	CORRECTED BY	DATE	CORRECTED BY	DATE
MICRO-FILM INFORMATION	DATE	MICRO-FILM INFORMATION	DATE	MICRO-FILM INFORMATION	DATE	MICRO-FILM INFORMATION	DATE
RECORDED BY	DATE	RECORDED BY	DATE	RECORDED BY	DATE	RECORDED BY	DATE
NO.	DATE	NO.	DATE	NO.	DATE	NO.	DATE

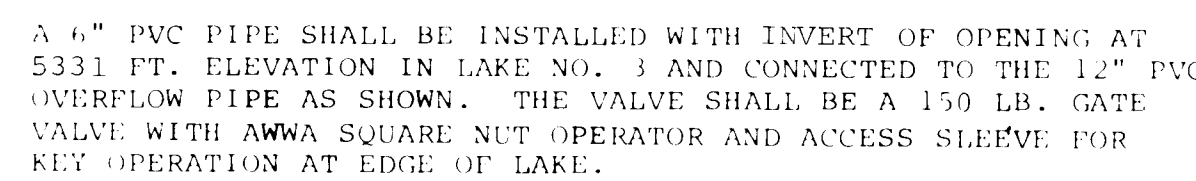

A RESERVOIR INLET SCREEN SHALL BE PROVIDED AT THE INLET TO THE HORIZONTAL 24" O.D. INDUCTION TUBE LEADING FROM THE LAKE TO THE PUMP STATION. ALL OF THE SCREEN SHALL BE IN A VERTICAL PLANE WITH A SCREEN AREA OF 36 SQUARE FEET. THE SCREEN SHALL BE 16 GAUGE, TYPE 304, FLATTENED STAINLESS STEEL EXPANDED METAL, WITH A MAXIMUM 3/8"x7/8" OPENINGS. THE BOTTOM AND LEGS SHALL BE CARBON STEEL AND SHALL BE EPOXY COATED TO A THICKNESS OF NOT LESS THAN 4 MILS. THE SCREEN OUTLET CONNECTION SHALL BE COMPATIBLE WITH THE HORIZONTAL INDUCTION TUBE. INLET SCREEN SHALL BE AS MANUFACTURED BY KESLER INTERNATIONAL CORPORATION OF DENVER, COLORADO OR ACCEPTABLE EQUAL.

CITY OF ALBUQUERQUE MUNICIPAL DEVELOPMENT DEPARTMENT ENGINEERING DIVISION					
TITLE: ARROYO DEL OSO GOLF COURSE LAKE CONNECTIONS					
APPROVALS	ENGINEER	DATE	APPROVALS	ENGINEER	DATE
City Engineer	<i>[Signature]</i>	1-1-88	Liquid Waste	<i>PSO</i>	1/8/88
A.C.E. Design	<i>[Signature]</i>	1-1-88	Traffic	<i>PS</i>	1/11/88
A.C.E. Hydrology	<i>[Signature]</i>	1-8-88	Water	<i>PSO</i>	1/6/88
<i>[Signature]</i>	<i>[Signature]</i>				
DRAWING NO.	I - 2		MAP NO.	F19	SHEET 14 OF 16

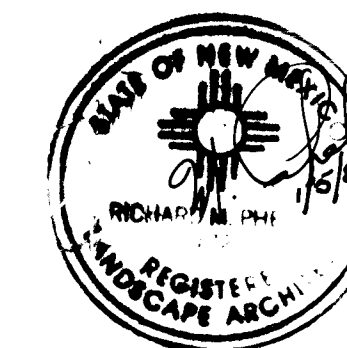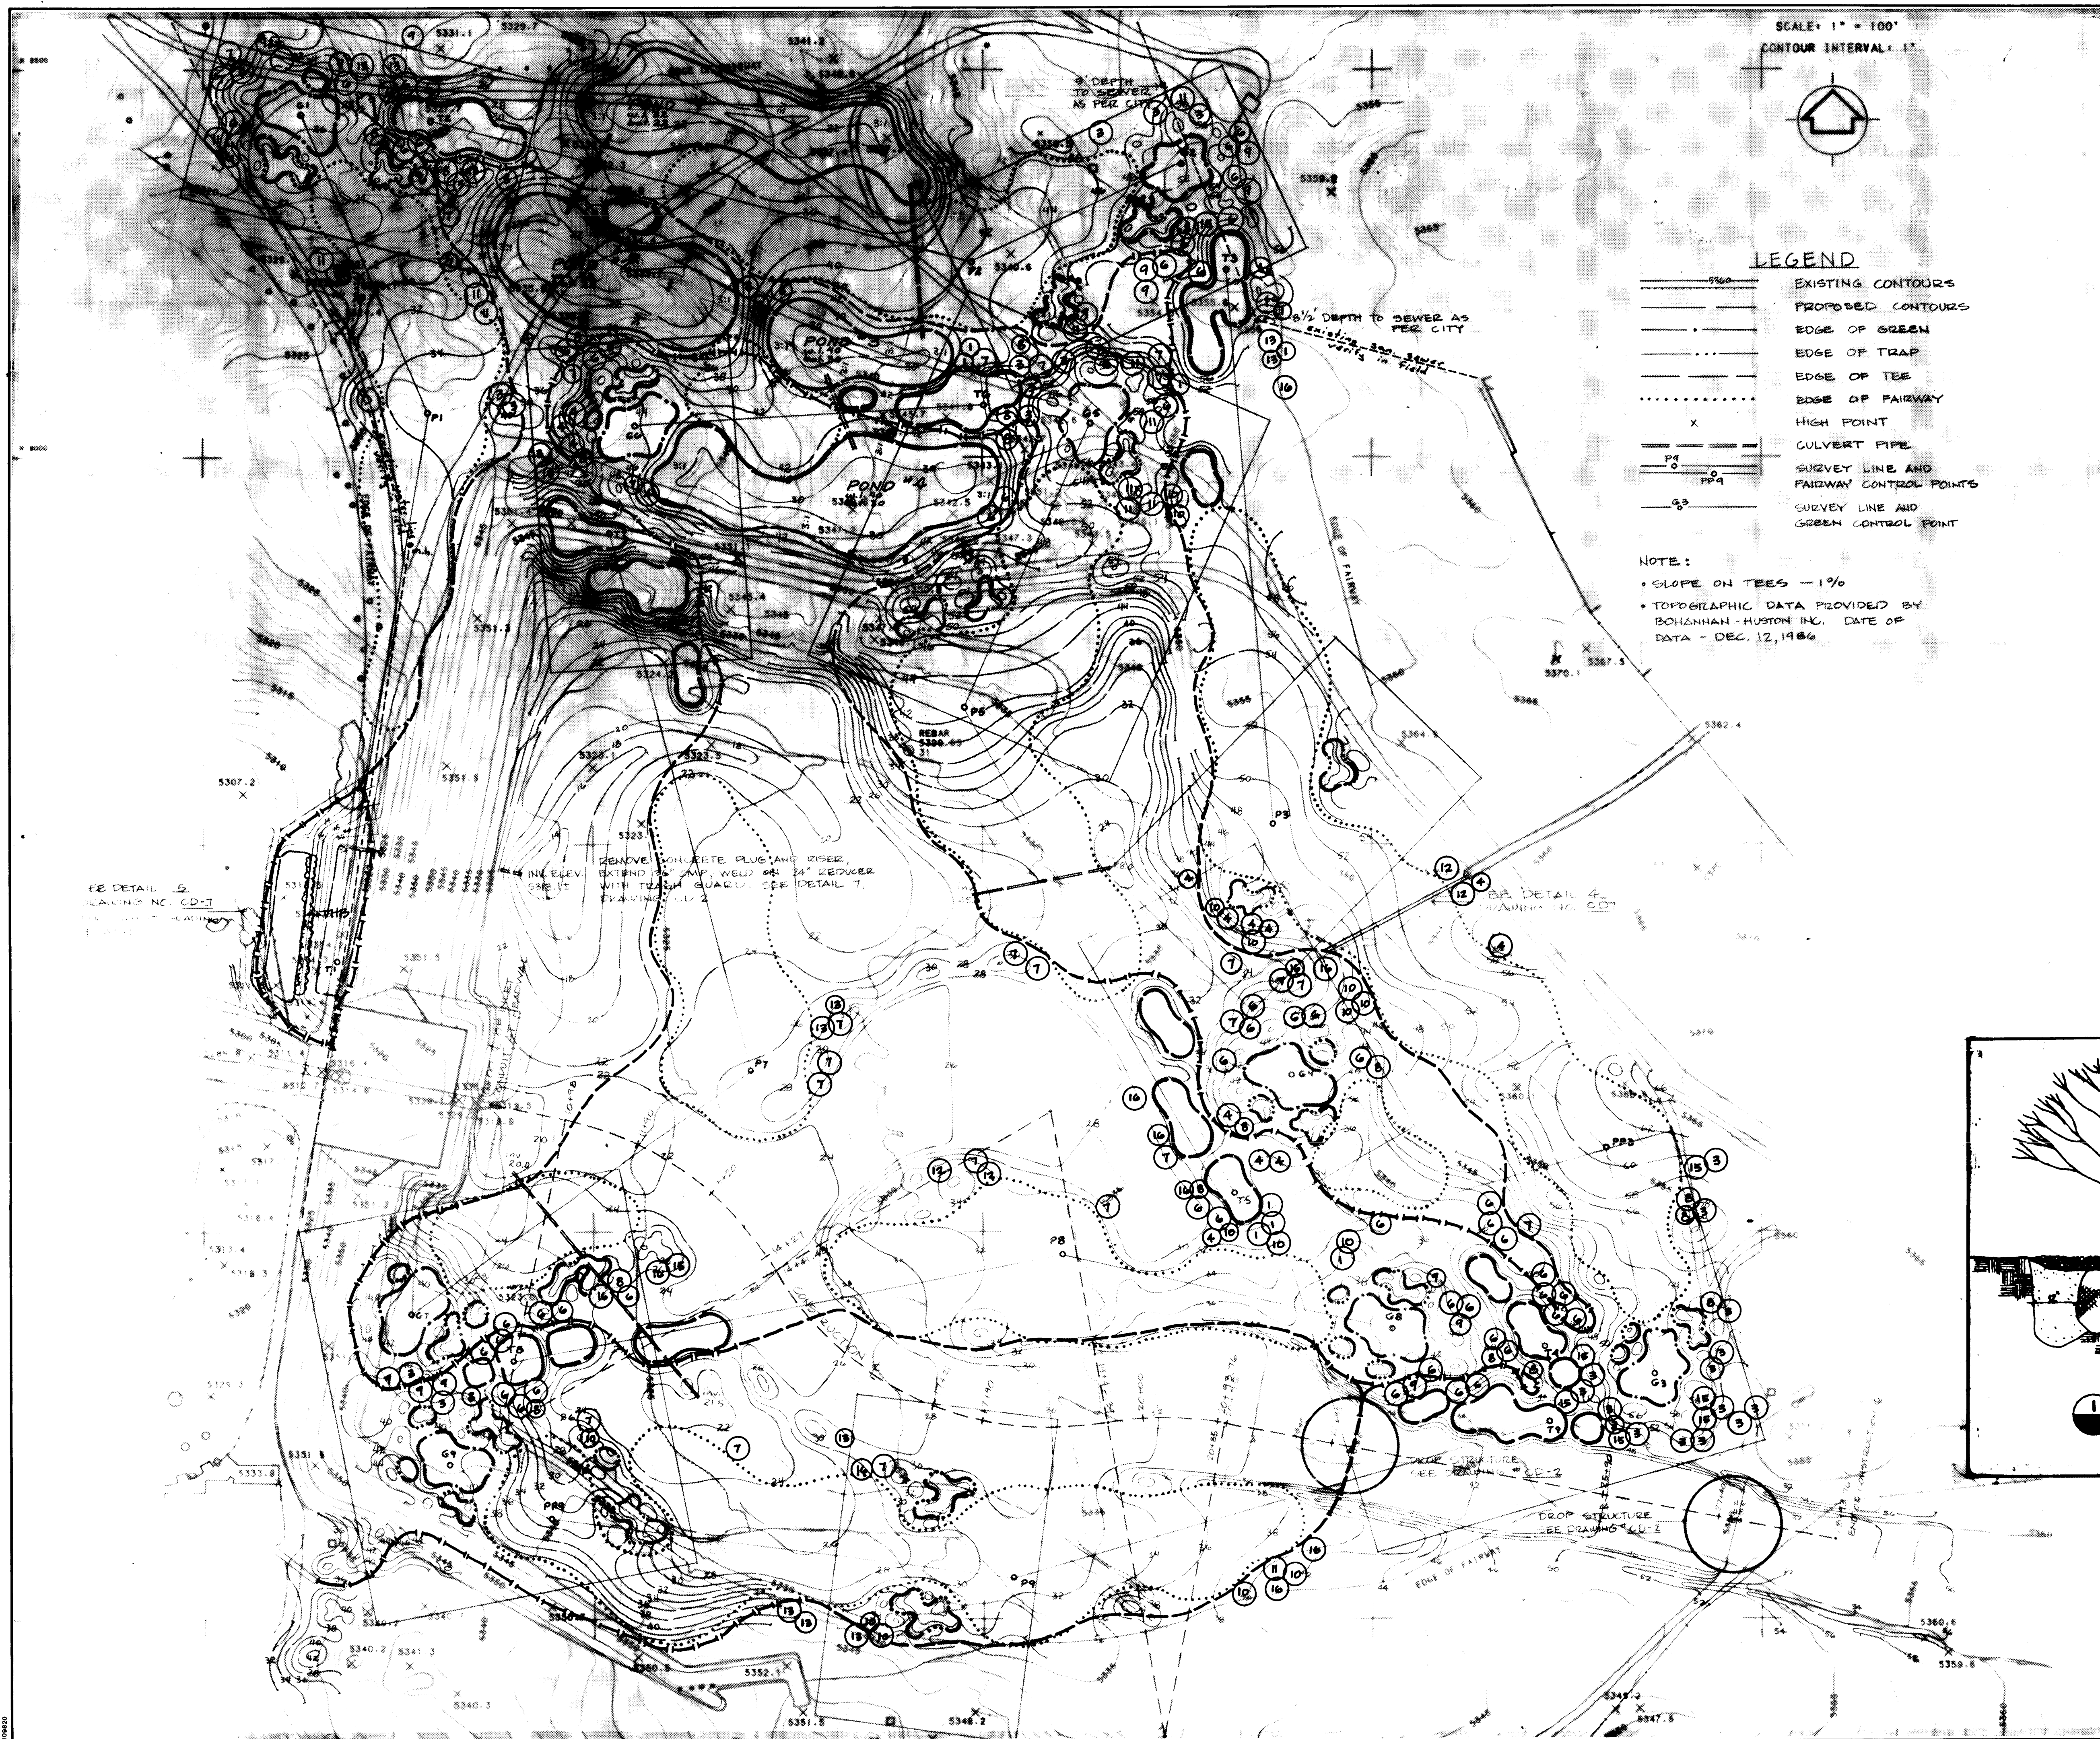

AS BUILT INFORMATION	
CONTRACTOR	
WORK STARTED BY	DATE
INSPECTOR'S APPROVAL BY	DATE
FIELD VERIFICATION BY	DATE
DRAWINGS CORRECTED BY	DATE
MICRO-FILM INFORMATION	
RECORDED BY	DATE
NO.	

[illegible]

ENGINEER'S SEAL

[illegible]

ROQUE DEPARTMENT SION	
RSE 9-HOLE ADDITION	
ART PATHS	
COVALS	ENGINEER
Waste	RENO
affic	RENO
ater	RENO
DATE	
1/8/81	
1/8/81	
1/8/81	
SHEET	15 OF 16

PLANT LIST				
KEY	PLANT NAME	NO.	SIZE	COMMENT
	1 KOSTER BLUE CEDRUS	11	6'	B 4 B
	2 ICEA FUNGUS KOSTER			
	3 INCHU PINE	NONE	THIS	PHASE
	4 PINUS EDULIS			
	5 PANDEROSA PINE	27	6'	B 4 B
	6 PINUS PANDEROSA			
	7 SCOTCH PINE	15	6'	B 4 B
	8 PINUS SYLVESTRIS			
	9 CYPRESS	NONE	THIS	PHASE
	10 CUPRESSUS GARYI			
	11 MOUNT GREEN GAY	58	1 1/2"	CONT.
	12 FRAXINUS PENN. LANCEOLATA			
	13 LANCELEAF COTTONWOOD	25	" "	
	14 POPULUS ALGINATA			
	15 BECHTEL CRABAPPLE	24	" "	
	16 MALUS SP. BECHTEL			
	17 HACKBERRY	13	" "	
	18 CELTIS OCCIDENTALIS			
10	19 HAWTHORN	15	" "	
	20 CRATAEGUS AGES-CALLI			
	21 SHADENAGUS HONEYLOCUST	13	" "	
	22 GLISTRIA TRIACANTHOS			
	23 MINOSA	4	18"	" "
	24 ALBIZIA JULIBRISIN			
	25 MULBERRY (SEEDLESS)	12	1 1/2"	" "
	26 MORUS ALBA "FRUITLESS"			
	27 PURPLELEAF PLUM	NONE	THIS	PHASE
	28 PRUNUS CERASIFERA ATROPURPUREA			
15	29 RUSSIAN OLIVE	9	1 1/2"	CONT.
	30 ELAEAGNUS ANGUSTIFOLIA			
16	31 GLOBE WILLOW	12	" "	
	32 SALIX MATROUDIANA UMBRACULIFERA			
THE	33 TALL HEDGE BUCKTHORN	40	6'	" "
	34 RHAMNUS FRANKOLIA "COLUMBIENSIS"			2' O.C.


LEGEND THIS SHEET

—————|—————|—————|—————|—————
CART PATHS - 1ST PHASE

—————
CART PATHS - FUTURE PHASE


⑥
TREE LOCATION AND KEY NO.

~~~~~  
HERDS - COLUMNAR BURKHOTHEN

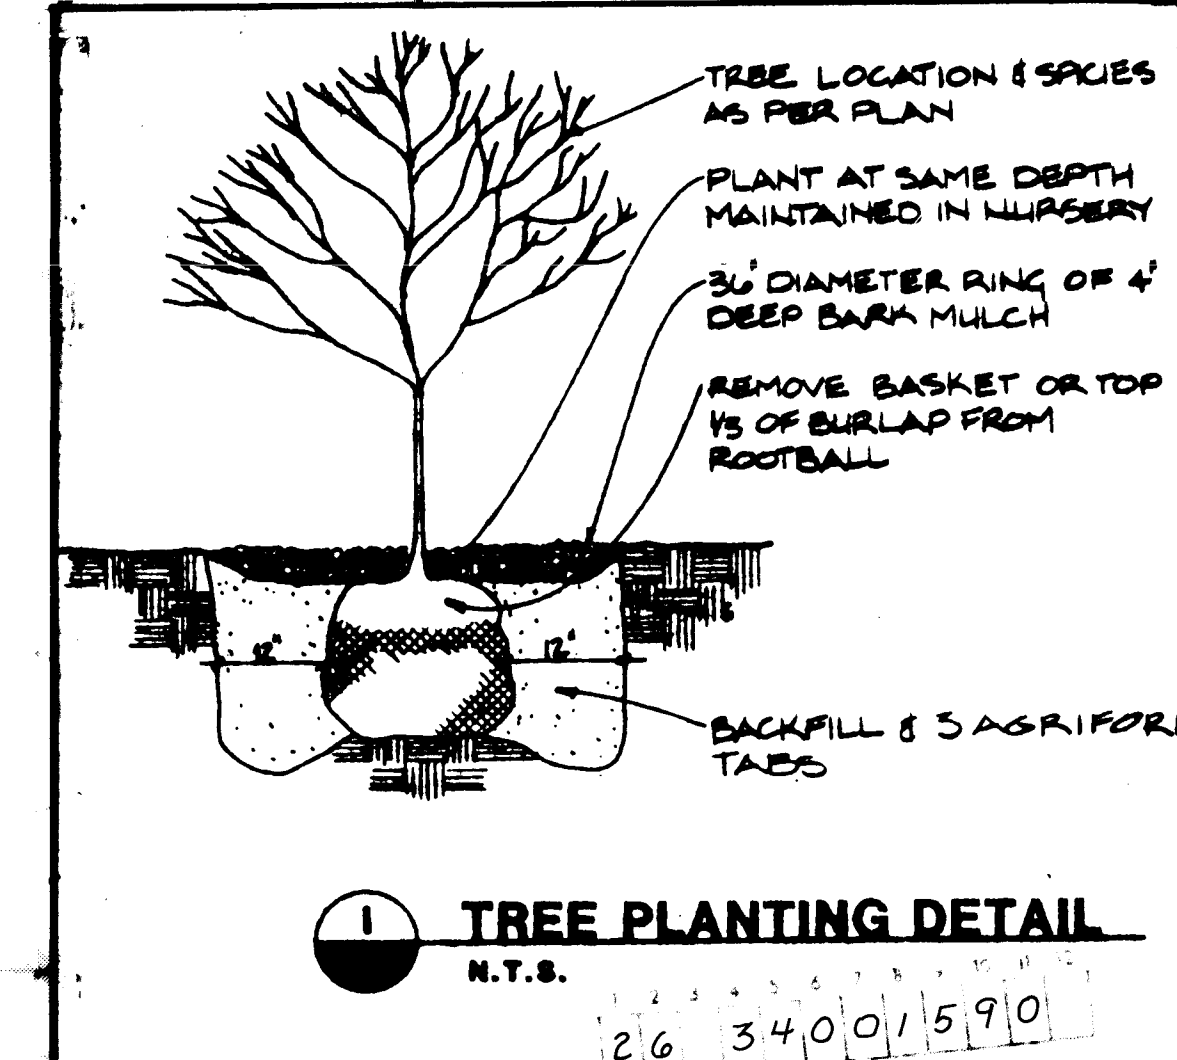


|                                                                                                                                |                    |         |              |                    |        |
|--------------------------------------------------------------------------------------------------------------------------------|--------------------|---------|--------------|--------------------|--------|
| <p align="center"><b>CITY OF ALBUQUERQUE</b><br/> <b>MUNICIPAL DEVELOPMENT DEPARTMENT</b><br/> <b>ENGINEERING DIVISION</b></p> |                    |         |              |                    |        |
| <p><b>TITLE: ARROYO DEL OSO GOLF COURSE 9-HOLE ADDITION</b></p>                                                                |                    |         |              |                    |        |
| <p align="center"><b>PLANTING PLAN/CART PATHS</b></p>                                                                          |                    |         |              |                    |        |
| APPROVALS                                                                                                                      | ENGINEER           | DATE    | APPROVALS    | ENGINEER           | DATE   |
| City Engineer                                                                                                                  | <i>[Signature]</i> | 1-11-88 | Liquid Waste | <i>[Signature]</i> | 1/8/88 |
| A.C.E. Design                                                                                                                  | <i>[Signature]</i> | 1-11-88 | Traffic      | <i>[Signature]</i> | 1/8/88 |
| A.C.E. Hydrology                                                                                                               | <i>[Signature]</i> | 1-8-88  | Water        | <i>[Signature]</i> | 1/8/88 |
| <i>[Signature]</i>                                                                                                             | <i>[Signature]</i> | 1-7-88  |              |                    |        |
| DRAWING NO.                                                                                                                    | PP1                |         | MAP NO.      | F-19               |        |
|                                                                                                                                |                    |         | SHEET        | 15                 | OF 16  |



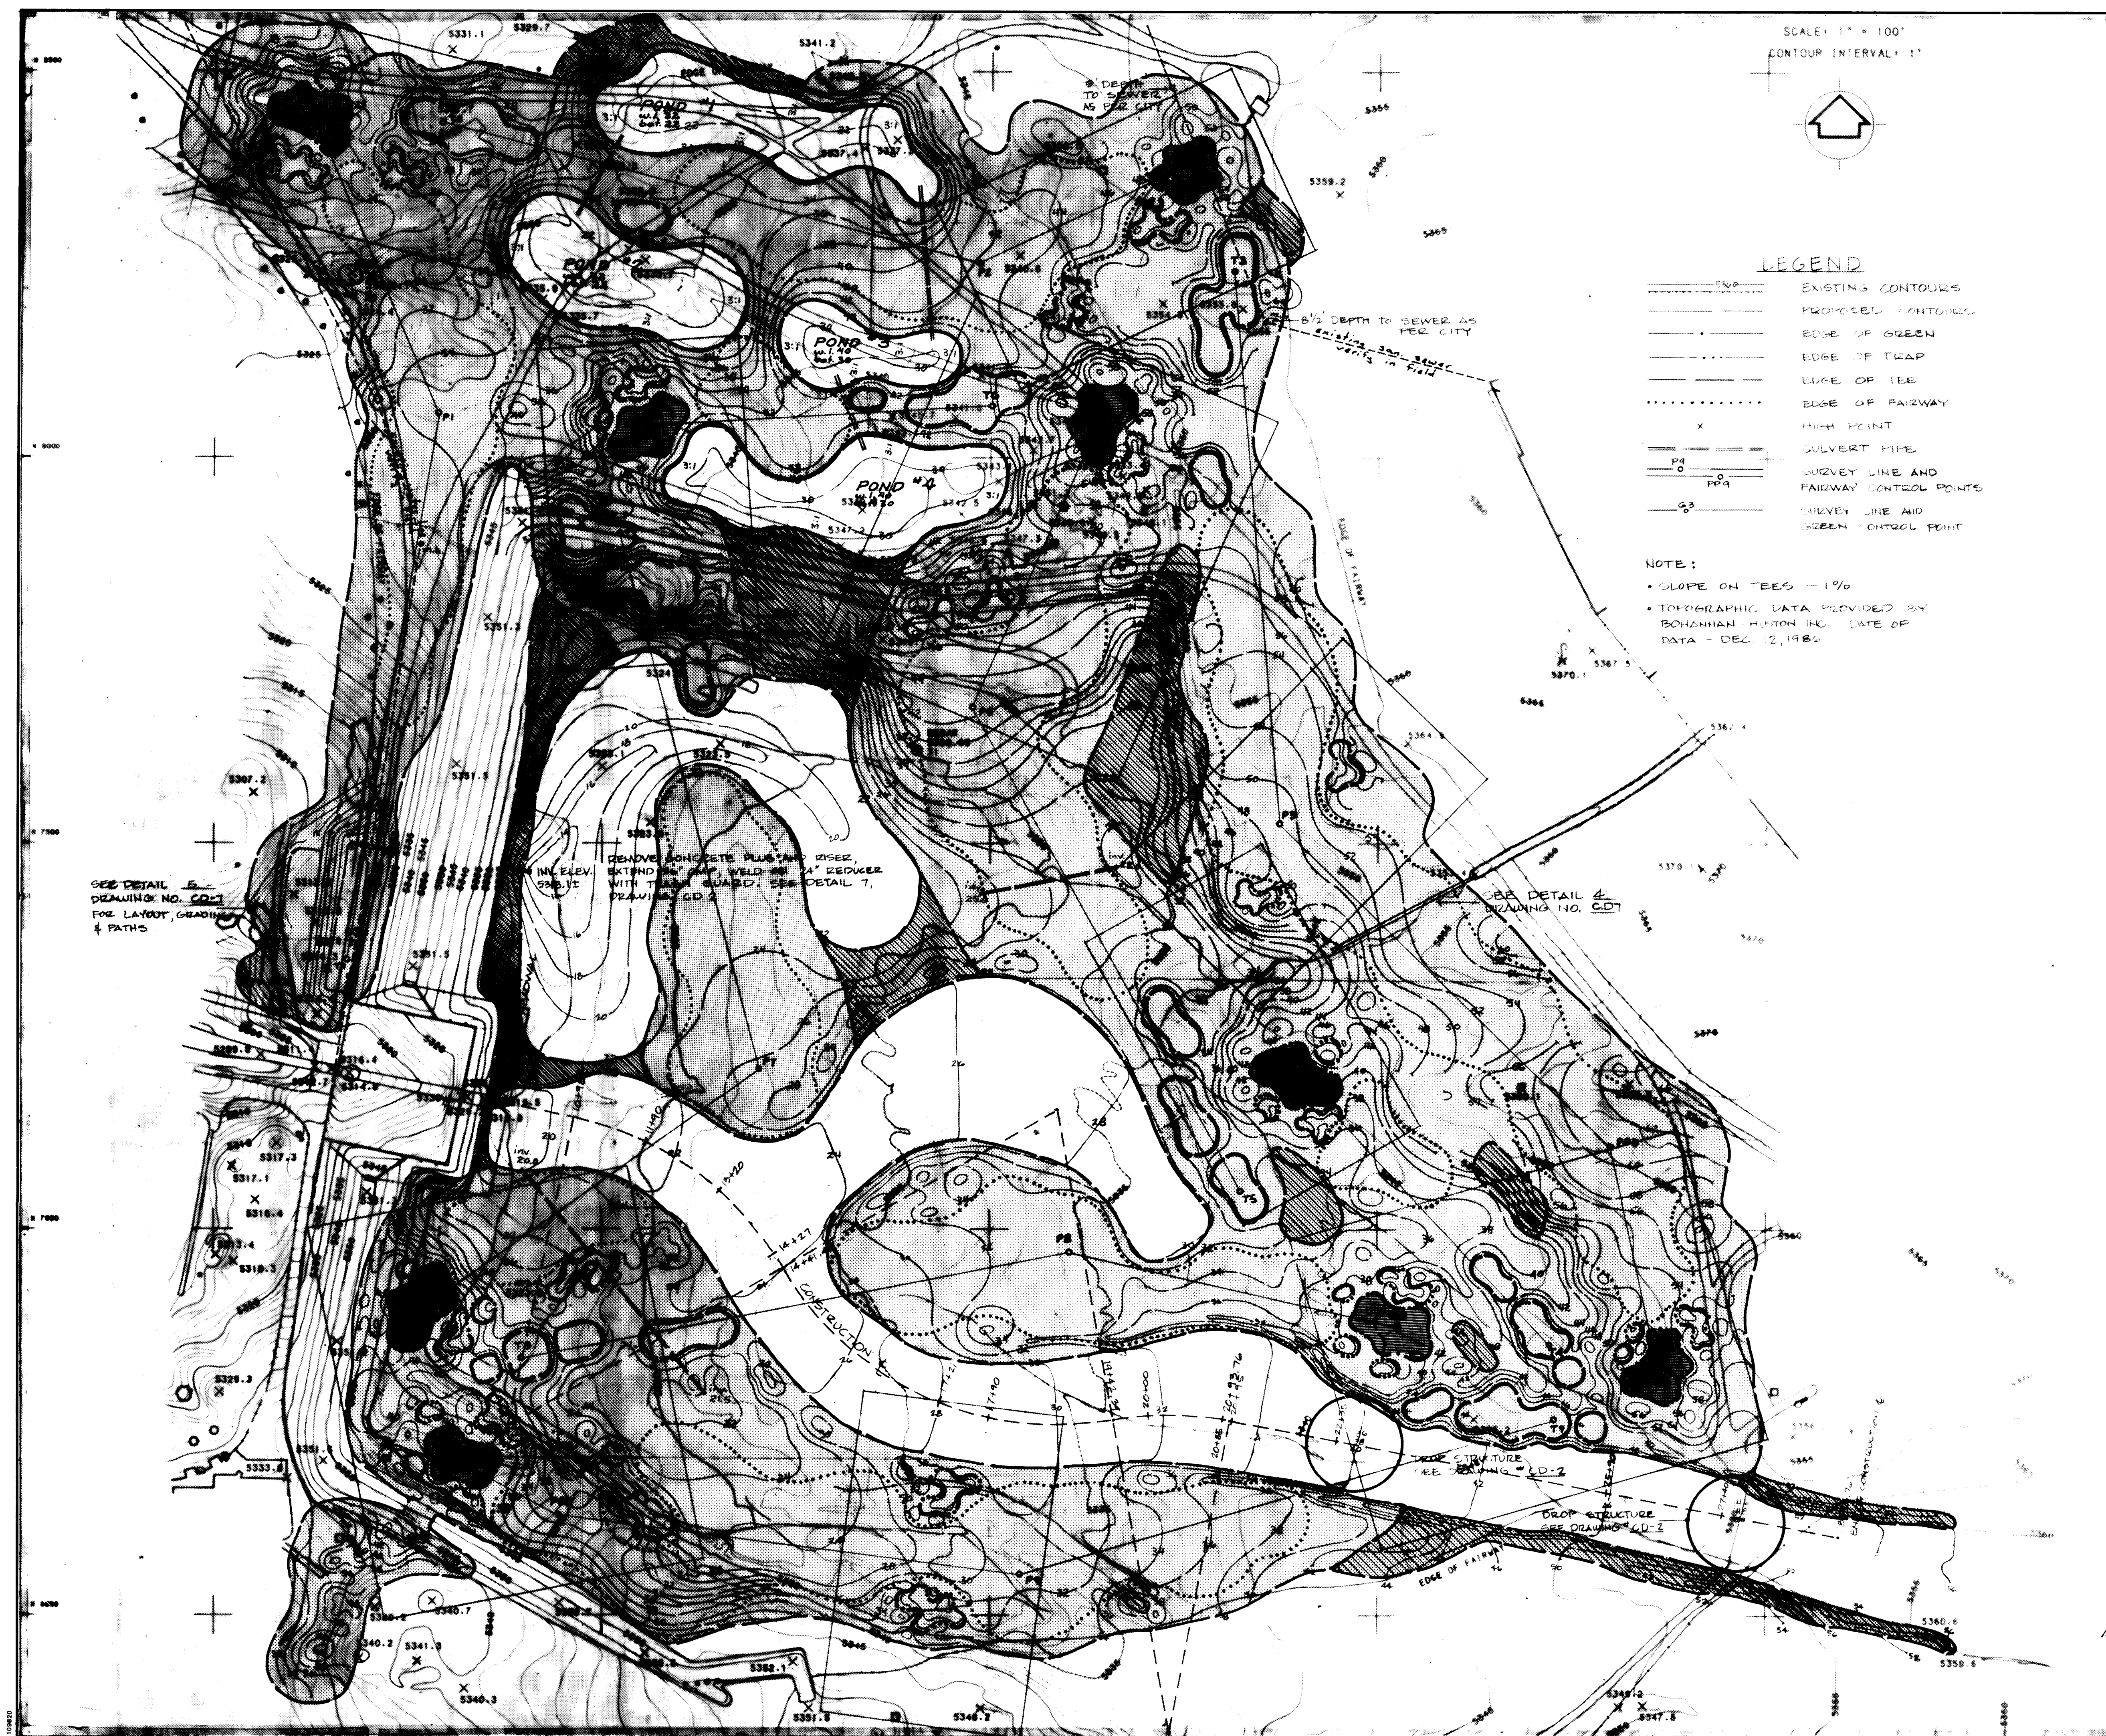

SCALE: 1" = 100'  
CONTOUR INTERVAL: 1'

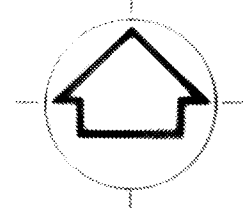

### LEGEND

- EXISTING CONTOURS
- PROPOSED CONTOURS
- EDGE OF GREEN
- EDGE OF TRAP
- EDGE OF TEE
- EDGE OF FAIRWAY
- HIGH POINT
- CULVERT PIPE
- SURVEY LINE AND FAIRWAY CONTROL POINTS
- SURVEY LINE AND GREEN CONTROL POINT

NOTE:  
• SLOPE ON TEES - 1%  
• TOPOGRAPHIC DATA PROVIDED BY BOHANNAN-HUTON INC. DATE OF DATA - DEC. 12, 1980

### LEGEND SEEDING

- GREENS - SEASIDE BENTGRASS
- IRRIGATED TEES, FAIRWAYS AND ROUGH - SCOTT'S BLEND
- NON-IRRIGATED ROUGH - NATIVE MIXTURE



SEE DETAIL 5, DRAWING NO. 607 FOR LAYOUT, GRADING & PATHS

REMOVE CONCRETE PLUG AND RISER, EXTEND 12" CAP WELD IN 4" REDUCER WITH TIGHT GASKET. SEE DETAIL 7, DRAWING NO. 607

SEE DETAIL 4, DRAWING NO. 607

26 34001690

CITY OF ALBUQUERQUE  
MUNICIPAL DEVELOPMENT DEPARTMENT  
ENGINEERING DIVISION

### TITLE: ARROYO DEL OSO GOLF COURSE 9-HOLE ADDITION SEEDING PLAN

| APPROVALS        | ENGINEER           | DATE     | APPROVALS    | ENGINEER           | DATE     |
|------------------|--------------------|----------|--------------|--------------------|----------|
| City Engineer    | <i>[Signature]</i> | 11-11-88 | Liquid Waste | <i>[Signature]</i> | 11/18/88 |
| A.C.E. Design    | <i>[Signature]</i> | 11-11-88 | Traffic      | <i>[Signature]</i> | 11/18/88 |
| A.C. E-Hydrology | <i>[Signature]</i> | 11-11-88 | Water        | <i>[Signature]</i> | 11/18/88 |

DRAWING NO. **S1** MAP NO. **F-19** SHEET **16** OF **16**