



YALE BOULEVARD, NE. AND JOAN HILL PLACE, NE.

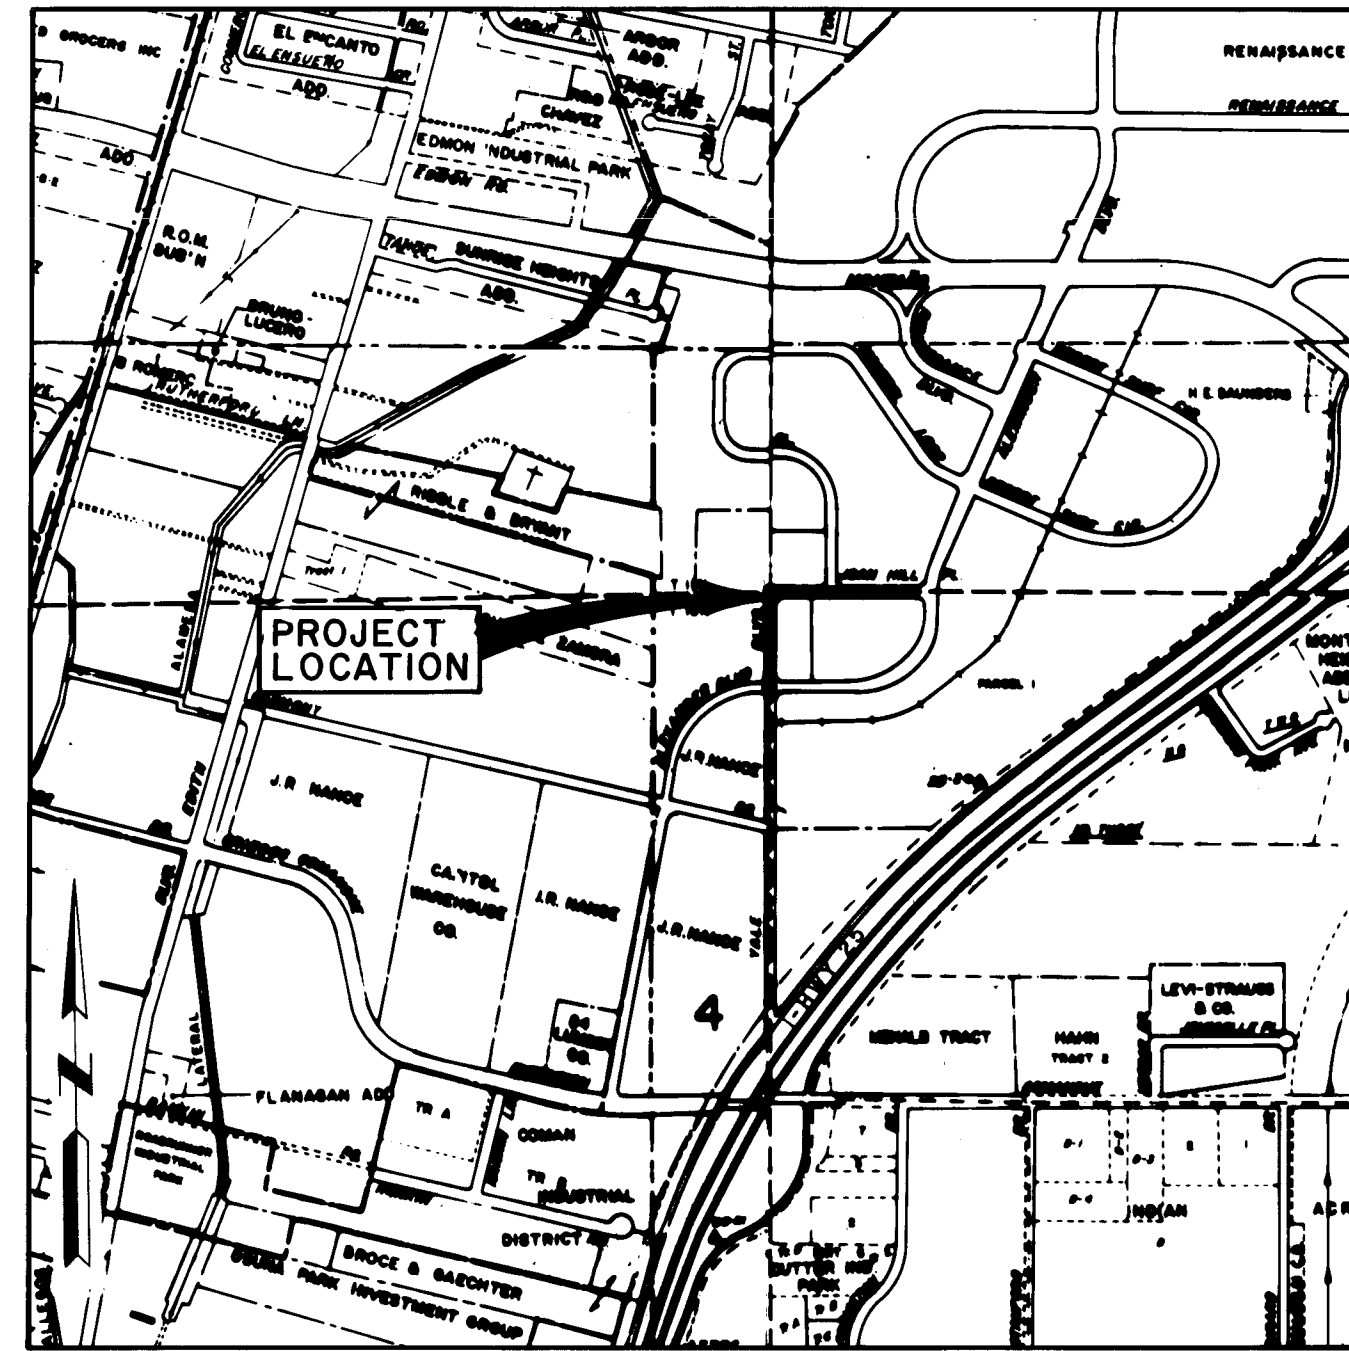

LOCATION MAP
ZONE ATLAS MAP G-16
SCALE 1"=1000'

DESCRIPTION	INDEX	SHEET NO.
TITLE SHEET, INDEX AND GENERAL NOTES	1	
REMOVAL PLAN	2	
PAVING PLAN & PROFILE		
YALE BOULEVARD, NE	3	
AMN SPUR LINE CROSSING - YALE BOULEVARD, NE.	3A	
JOAN HILL PLACE, NE.	4	
STREET SECTIONS & MISCELLANEOUS DETAILS.	5	
CROSS SECTIONS - JOAN HILL PLACE, NE	6	
STREET LIGHTING PLAN - ALEXANDER BLVD., NE	7	

CITY OF ALBUQUERQUE NEW MEXICO

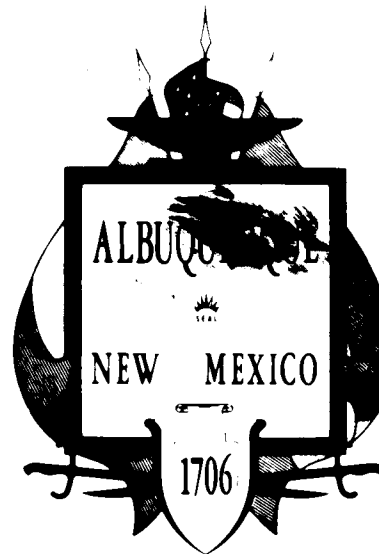

GENERAL NOTES

1. ALL WORK DETAILED ON THESE PLANS TO BE PERFORMED UNDER THIS CONTRACT SHALL, EXCEPT AS OTHERWISE STATED OR PROVIDED FOR HEREON, BE CONSTRUCTED IN ACCORDANCE WITH CITY OF ALBUQUERQUE STANDARD SPECIFICATIONS FOR PUBLIC WORKS CONSTRUCTION, 1986 EDITION.
 2. REFERENCES MADE TO STANDARD DRAWINGS REFER TO CITY OF ALBUQUERQUE STANDARD DRAWINGS.
 3. TWO WORKING DAYS PRIOR TO ANY EXCAVATION, CONTRACTOR MUST CONTACT LINE LOCATING SERVICE, 765-1234, FOR LOCATION OF EXISTING UTILITIES.
 4. PRIOR TO CONSTRUCTION, THE CONTRACTOR SHALL EXCAVATE AND VERIFY THE HORIZONTAL AND VERTICAL LOCATIONS OF ALL OBSTRUCTIONS. SHOULD A CONFLICT EXIST, THE CONTRACTOR WILL NOTIFY THE ENGINEER OR SURVEYOR SO THAT THE CONFLICT CAN BE RESOLVED WITH A MINIMUM AMOUNT OF DELAY.
 5. ALL UTILITIES AND UTILITY SERVICE LINES SHALL BE INSTALLED PRIOR TO PAVING.
 6. BACKFILL COMPACTION SHALL BE ACCORDING TO SPECIFIED STREET USE.
 7. TACK COAT REQUIREMENTS SHALL BE DETERMINED BY ENGINEER.
 8. CONTRACTOR SHALL PROVIDE 12" SUBGRADE PREPARATION UNDER ALL NEW PAVEMENT, CURBS & GUTTERS, VALLEY GUTTERS, AND CONCRETE FILLETS.
 9. WHEN ABUTTING NEW PAVEMENT TO EXISTING, CUT BACK EXISTING PAVEMENT TO A NEAT STRAIGHT LINE AS REQUIRED TO REMOVE ANY BROKEN OR CRACKED PAVEMENT, AND MATCH NEW TO EXISTING. NO SEPARATE PAYMENT SHALL BE MADE FOR SUCH CUTTING OF EXISTING PAVEMENT BUT SHALL BE CONSIDERED INCIDENTAL TO THE PROJECT. CUTTING OF PAVEMENT SHALL BE IN CONFORMANCE WITH THE SPECIFICATIONS.
 10. CURB & GUTTER SHOWN AS EXISTING AND NOT TO BE REMOVED UNDER THE CONTRACT WHICH IS DAMAGED OR DISPLACED BY THE CONTRACTOR SHALL BE REMOVED AND REPLACED BY THE CONTRACTOR AT HIS EXPENSE.
 11. WHEN PAVEMENT CONSTRUCTION UNDER THIS PROJECT CONNECTS TO EXISTING IMPROVEMENTS, THE CONTRACTOR SHALL PROVIDE AN EASY RIDING CONNECTION.
 12. ALL WATER VALVE BOXES AND SEWER MANHOLES IN THE CONSTRUCTION AREA ARE TO BE ADJUSTED TO FINISH GRADE UNDER THE CONTRACT.
 13. CONTRACTOR SHALL REMOVE AND DISPOSE OF ALL OBJECTIONABLE MATERIAL FROM THE CONSTRUCTION SITE. A DISPOSAL SITE FOR ALL REMOVAL ITEMS SHALL BE OBTAINED BY THE CONTRACTOR. THE SITE SHALL BE IN COMPLIANCE WITH APPLICABLE ENVIRONMENTAL REGULATIONS AND APPROVED BY THE CITY ENGINEERING DEPARTMENT. ALL COSTS INCURRED IN OBTAINING AN ACCEPTABLE SITE AND HAUL THERETO SHALL BE CONSIDERED INCIDENTAL TO CONSTRUCTION OF THE PROJECT.
- (SEE SHEET 2 FOR CONTINUATION OF GENERAL NOTES)


APPROVAL OF AS BUILT DRAWINGS
CHIEF CONSTRUCTION ENGINEER
[Signature]
DATE 4/17/90

REV	SHEETS	CITY ENGR.	DATE	USER	DEPT.	DATE	USER	DEPT.	DATE
1	3	3A	10/1/89	R. D. Davis	10-19-89				
APPROVAL OF REVISIONS									

26 37010190

SET NUMBER

	ANDREWS, ASBURY & ROBERT, INC. CONSULTING ENGINEERS ALBUQUERQUE NEW MEXICO	APPROVED FOR CONSTRUCTION <i>[Signature]</i> CITY ENGINEER DATE 1/12/89
	3701	SHEET 1 OF 7

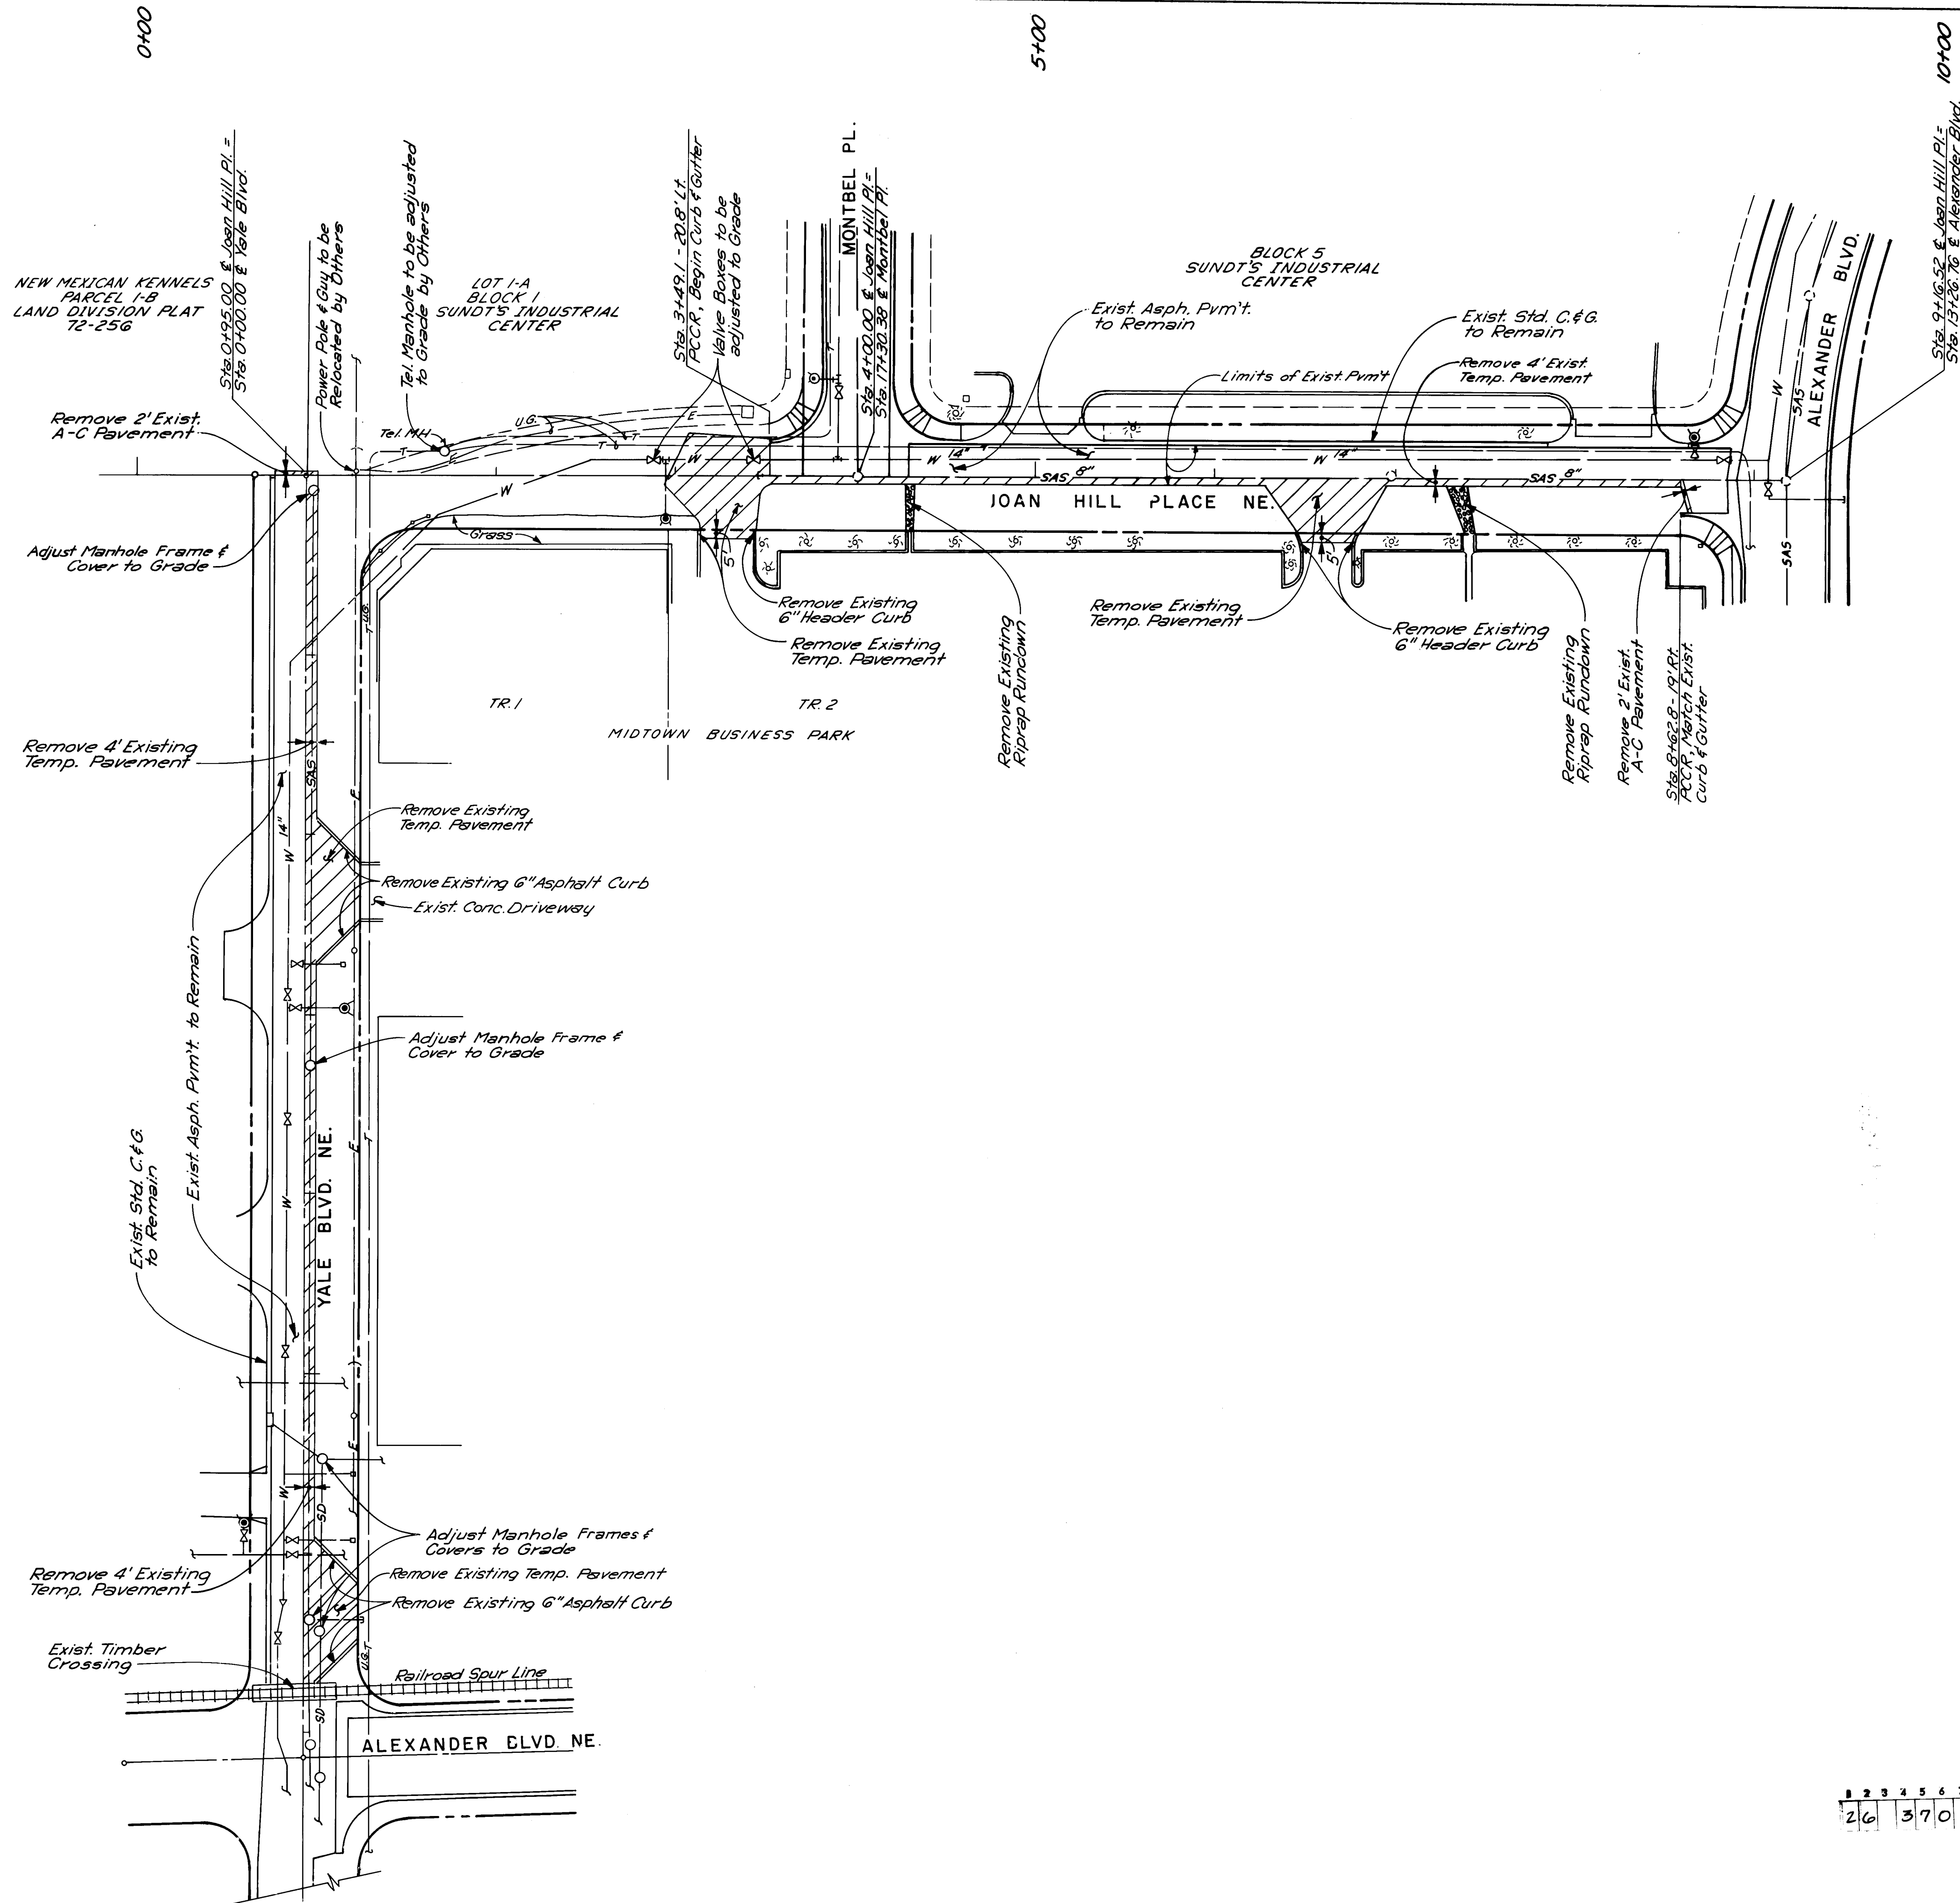

PLAN
SCALE: 1" = 50'

GENERAL NOTES (CONT.)

14. ALL PERMANENT PAVEMENT MARKING AND TRAFFIC SIGNING WILL BE PERFORMED BY THE CITY OF ALBUQUERQUE, TRAFFIC ENGINEERING DEPARTMENT.
15. CONSTRUCTION SIGNING:
 - A. ALL BARRICADES AND SIGNING SHALL CONFORM TO APPLICABLE SECTIONS OF THE "MANUAL ON UNIFORM TRAFFIC CONTROL DEVICES" (MUTCD), U.S. DEPARTMENT OF TRANSPORTATION, LATEST EDITION.
 - B. CONTRACTOR SHALL PREPARE A CONSTRUCTION SIGNING PLAN AND OBTAIN APPROVAL OF SUCH PLAN FROM THE CITY OF ALBUQUERQUE, TRAFFIC ENGINEERING DEPARTMENT, PRIOR TO BEGINNING ANY CONSTRUCTION WORK ON OR ADJACENT TO EXISTING STREETS.
 - C. ALL CONSTRUCTION WARNING SIGNS SHALL HAVE A MOUNTED HEIGHT OF SEVEN (7) FEET.
 - D. CONTRACTOR SHALL MAINTAIN ALL BARRICADES AND SIGNING AT ALL TIMES. THE CONTRACTOR SHALL VERIFY THE PROPER LOCATION OF ALL BARRICADES AT THE END AND BEGINNING OF EACH DAY.
16. MEASUREMENT FOR PAYMENT OF SUBGRADE PREPARATION FOR ROADWAY PAVEMENT WILL BE MADE ALONG THE PLANE OF THE WORK AND FROM LIP OF GUTTER TO LIP OF GUTTER OR EDGE OF PAYMENT AS APPLICABLE. (SEE NOTE 18 FOR PAYMENT OF OTHER SUBGRADE PREPARATION).
17. SUBGRADE PREPARATION UNDER CURB & GUTTER INCLUDING ONE FOOT BEHIND BACK OF CURB, SHALL BE CONSIDERED INCIDENTAL TO THE CONSTRUCTION OF SUCH AND SHALL BE INCLUDED IN THE BID PRICE FOR CURB AND GUTTER.
18. MEASUREMENT AND PAYMENT FOR GRADING AREAS TO BE PAVED SHALL BE FROM RIGHT-OF-WAY LINE TO RIGHT-OF-WAY LINE OR TO EDGE OF EXISTING PAVEMENT TO REMAIN, WHICHEVER IS LESS.
19. CTB SHALL BE PLACED FROM LIP OF GUTTER TO LIP OF GUTTER OR EDGE OF EXISTING PAVEMENT TO REMAIN WHICHEVER IS LESS.

AS BUILT INFORMATION		BENCH MARKS		SURVEY INFORMATION		ENGINEER'S SEAL	
CONTRACTOR	DATE	AS/INCHES STA.	DATE	NO.	BY	NO.	BY
PRIDE CONSTRUCTION	C.O.A.	1-25-20"					
INSPECTOR	DATE	BRASS TABLET SET IN CONCRETE POST LOCATED ON THE					
VERIFICATION BY	DATE	WESTERLY R.O.W. LINE OF I-25, 0.5 MILES SOUTHWESTERLY					
VERIFICATION BY	DATE	FROM THE INTERSECTION WITH MONTANA RD.					
VERIFICATION BY	DATE	ELEV. 5079.46					
RECORDED BY	DATE						
NO.							

ENGINEER'S SEAL

ANDREW ASSURRY & ROBERT, INC.

REGISTERED PROFESSIONAL ENGINEER

STATE OF NEW MEXICO

NO. 10117

EXPIRATION DATE 12/31/2020

NO.	DATE	REVISIONS	DESIGN
1	4/13/89		
2	4/13/89		
3	4/13/89		
4	4/13/89		
5	4/13/89		
6	4/13/89		
7	4/13/89		
8	4/13/89		
9	4/13/89		
10	4/13/89		
11	4/13/89		
12	4/13/89		

DESIGNED BY JIM

DRAWN BY DG, JCS


CHECKED BY JIM, JA

DATE Nov 1988

DATE Dec 1988

DATE Dec 1988

CITY OF ALBUQUERQUE PUBLIC WORKS DEPARTMENT ENGINEERING GROUP			
YALE BOULEVARD NE. AND JOAN HILL PLACE NE. REMOVAL PLAN			
APPROVALS	ENGINEER	DATE	ENGINEER
D.R.C. Chair	Ryan J. Shaw	4/13/89	
Trans. Dev.	DEGO	4/13/89	
Utility Dev.			
DRAWING NO.	3701	MAP NO.	G-16
SHEET	2	OF	7


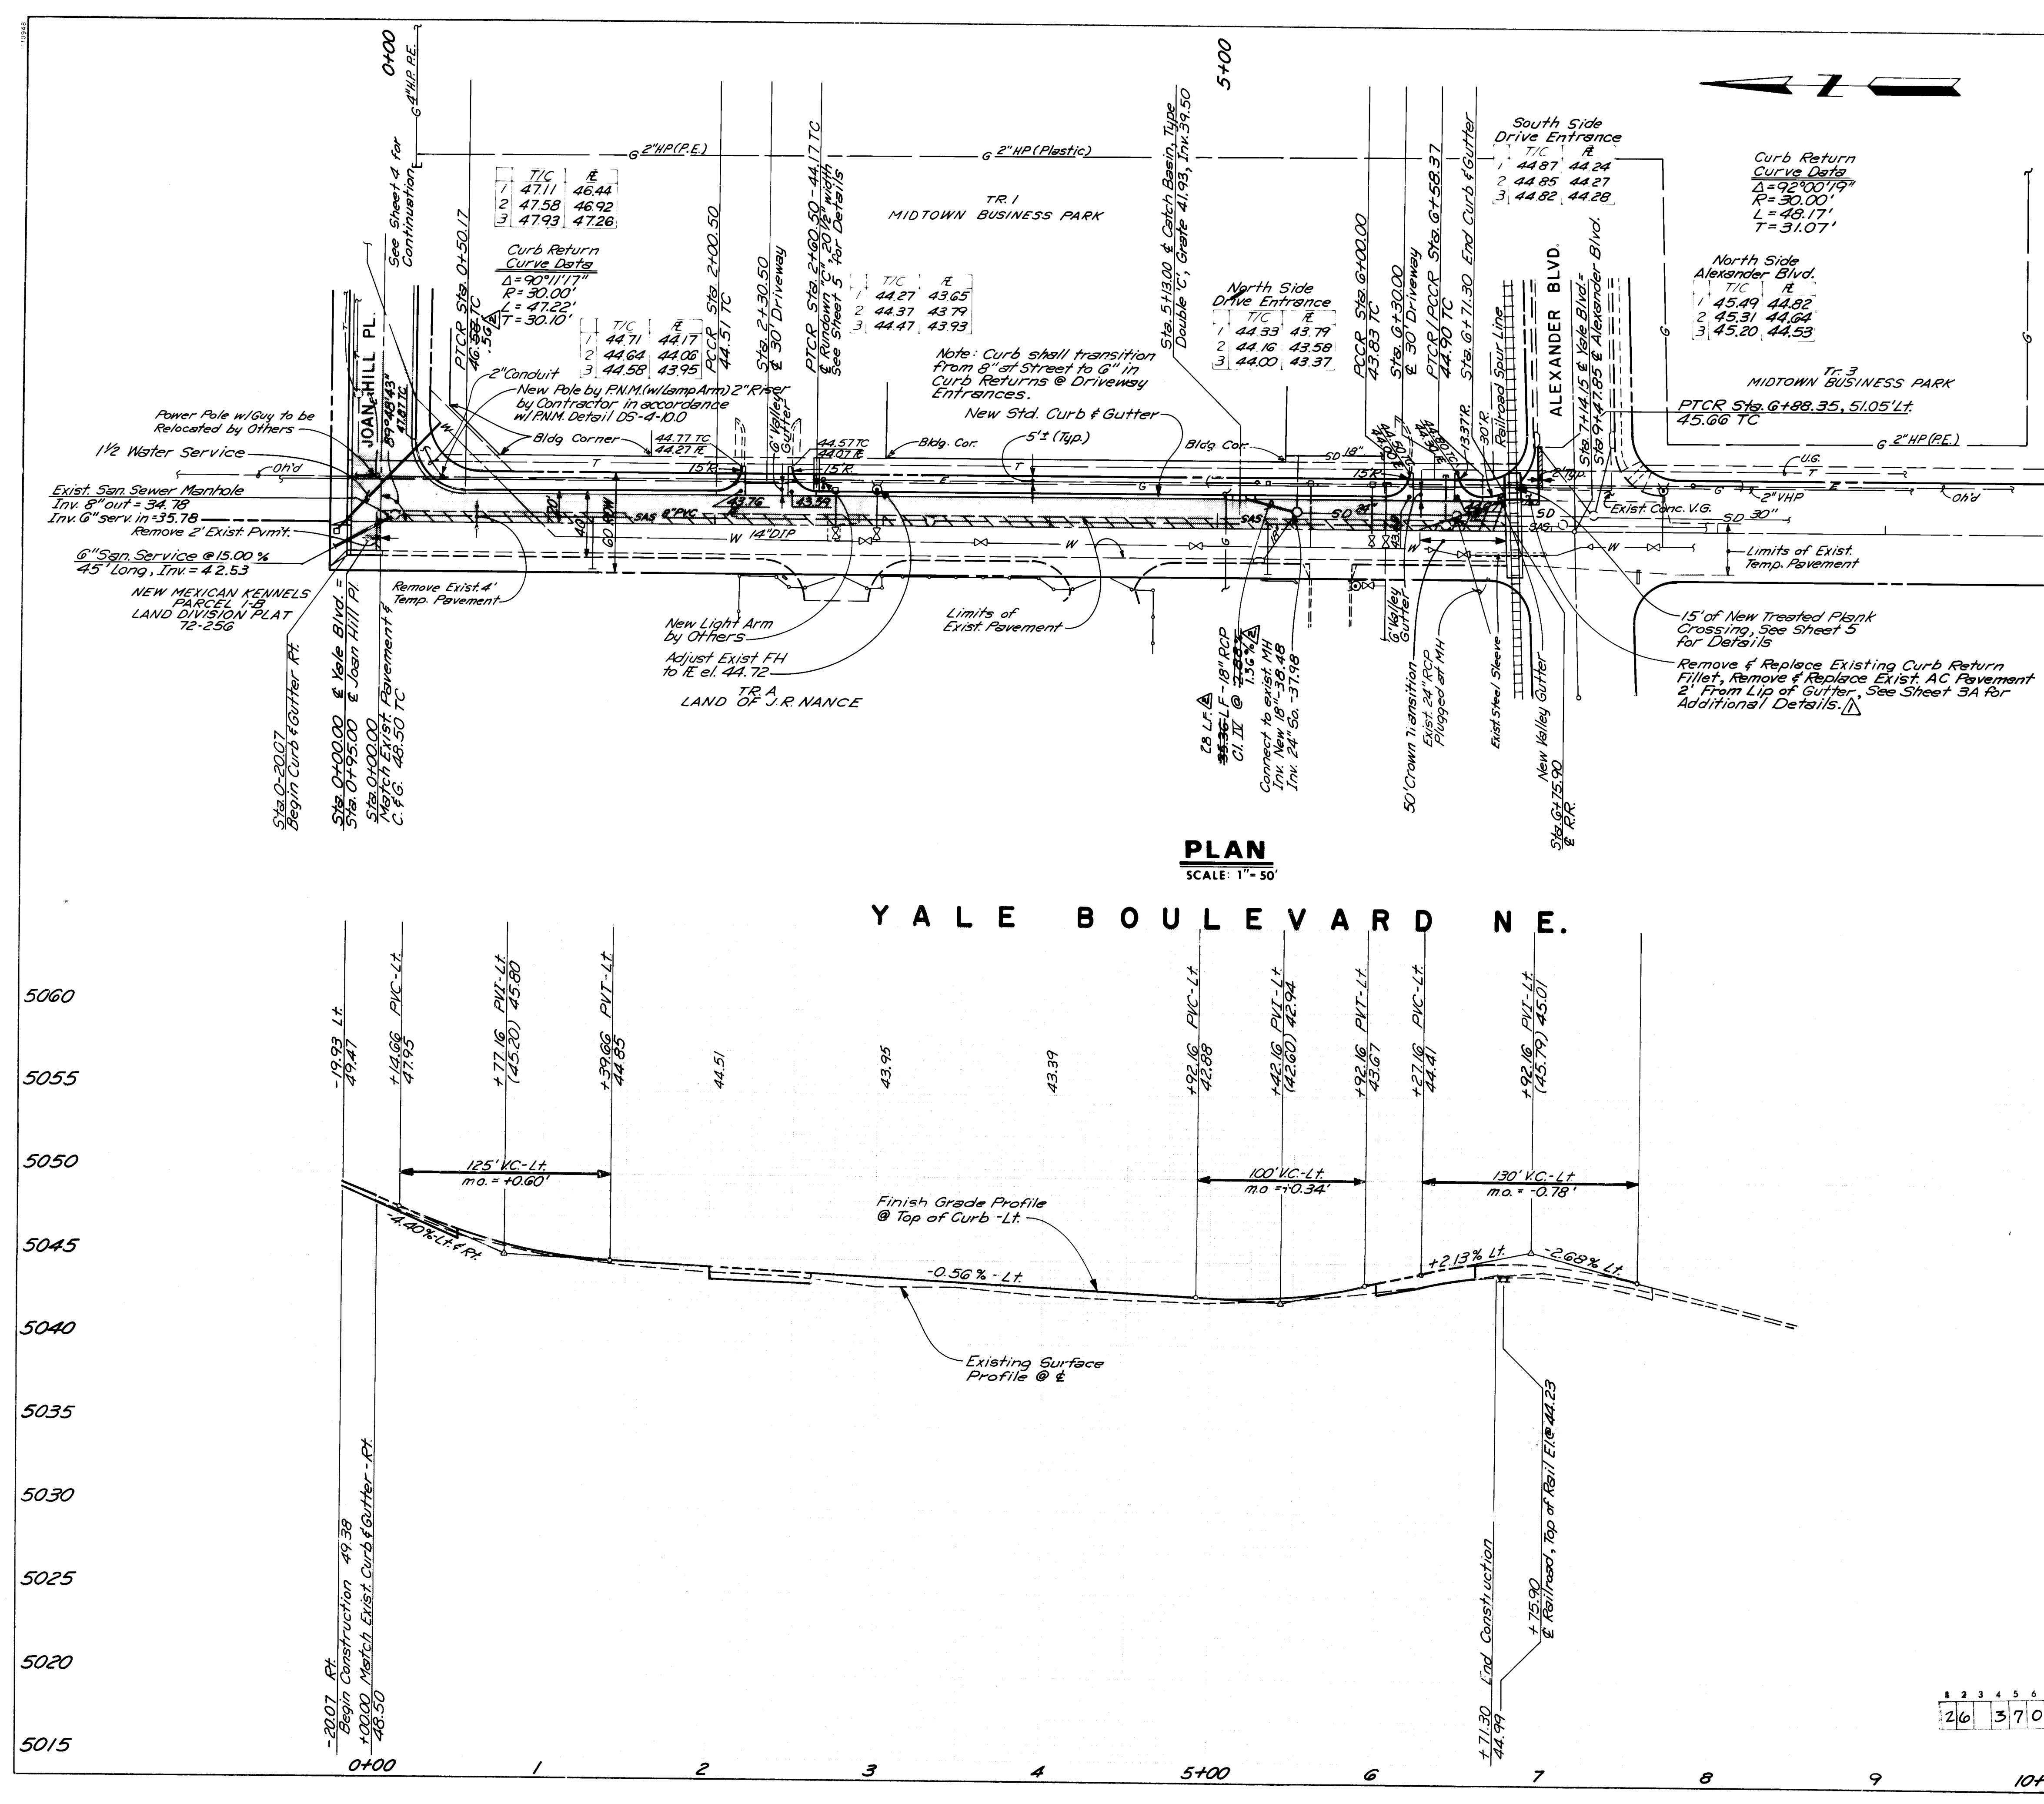


0+00 1 2 3 4 5+00 6 7 8 9 10+00

5060 5055 5050 5045 5040 5035 5030 5025 5020 5015


AS BUILT INFORMATION			BENCH MARKS			SURVEY INFORMATION			ENGINEER'S SEAL		
DATE	BY	NO.	DATE	BY	NO.	DATE	BY	NO.	DATE	BY	NO.
4/13/89	PEGO	4/10/89	4/13/89	PEGO	4/10/89	4/13/89	PEGO	4/10/89	4/13/89	PEGO	4/10/89
CITY OF ALBUQUERQUE PUBLIC WORKS DEPARTMENT ENGINEERING GROUP			YALE BOULEVARD NE. AND JOAN HILL PLACE NE. PAVING PLAN & PROFILE - YALE BOULEVARD NE.			APPROVALS			APPROVALS		
ENGINEER			ENGINEER			ENGINEER			ENGINEER		
DATE			DATE			DATE			DATE		
4/13/89			4/13/89			4/13/89			4/13/89		
DESIGNED BY			DESIGNED BY			DESIGNED BY			DESIGNED BY		
J.M.			J.M.			J.M.			J.M.		
DRAWN BY			DRAWN BY			DRAWN BY			DRAWN BY		
J.M.			J.M.			J.M.			J.M.		
CHECKED BY			CHECKED BY			CHECKED BY			CHECKED BY		
J.M.			J.M.			J.M.			J.M.		
DATE			DATE			DATE			DATE		
4/13/89			4/13/89			4/13/89			4/13/89		
REVISIONS			REVISIONS			REVISIONS			REVISIONS		
NO.			NO.			NO.			NO.		
1			1			1			1		
2			2			2			2		
3			3			3			3		
240			240			240			240		
24											

1-100

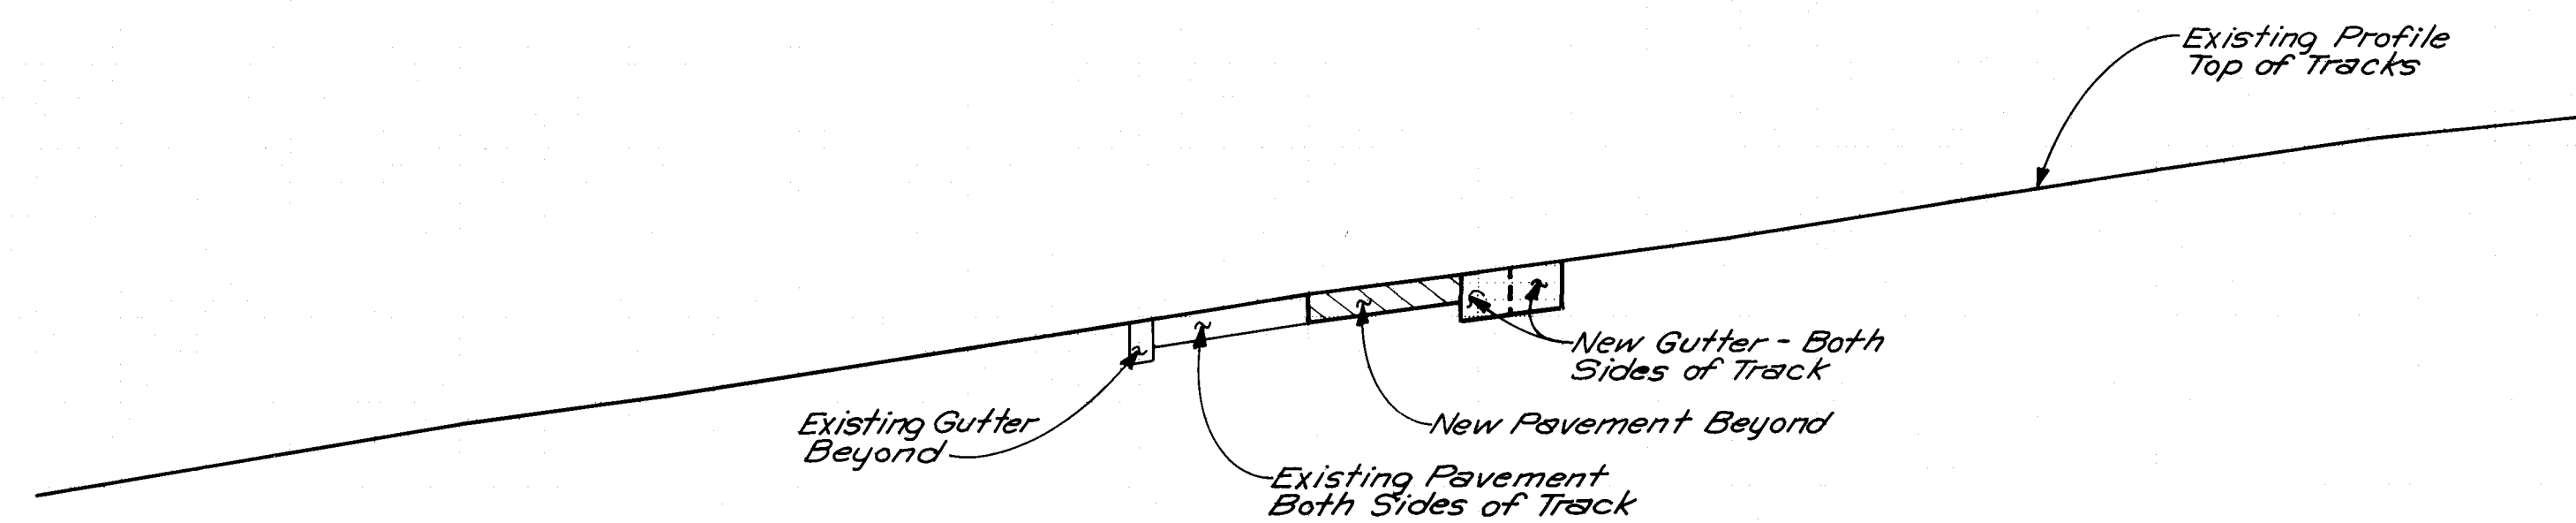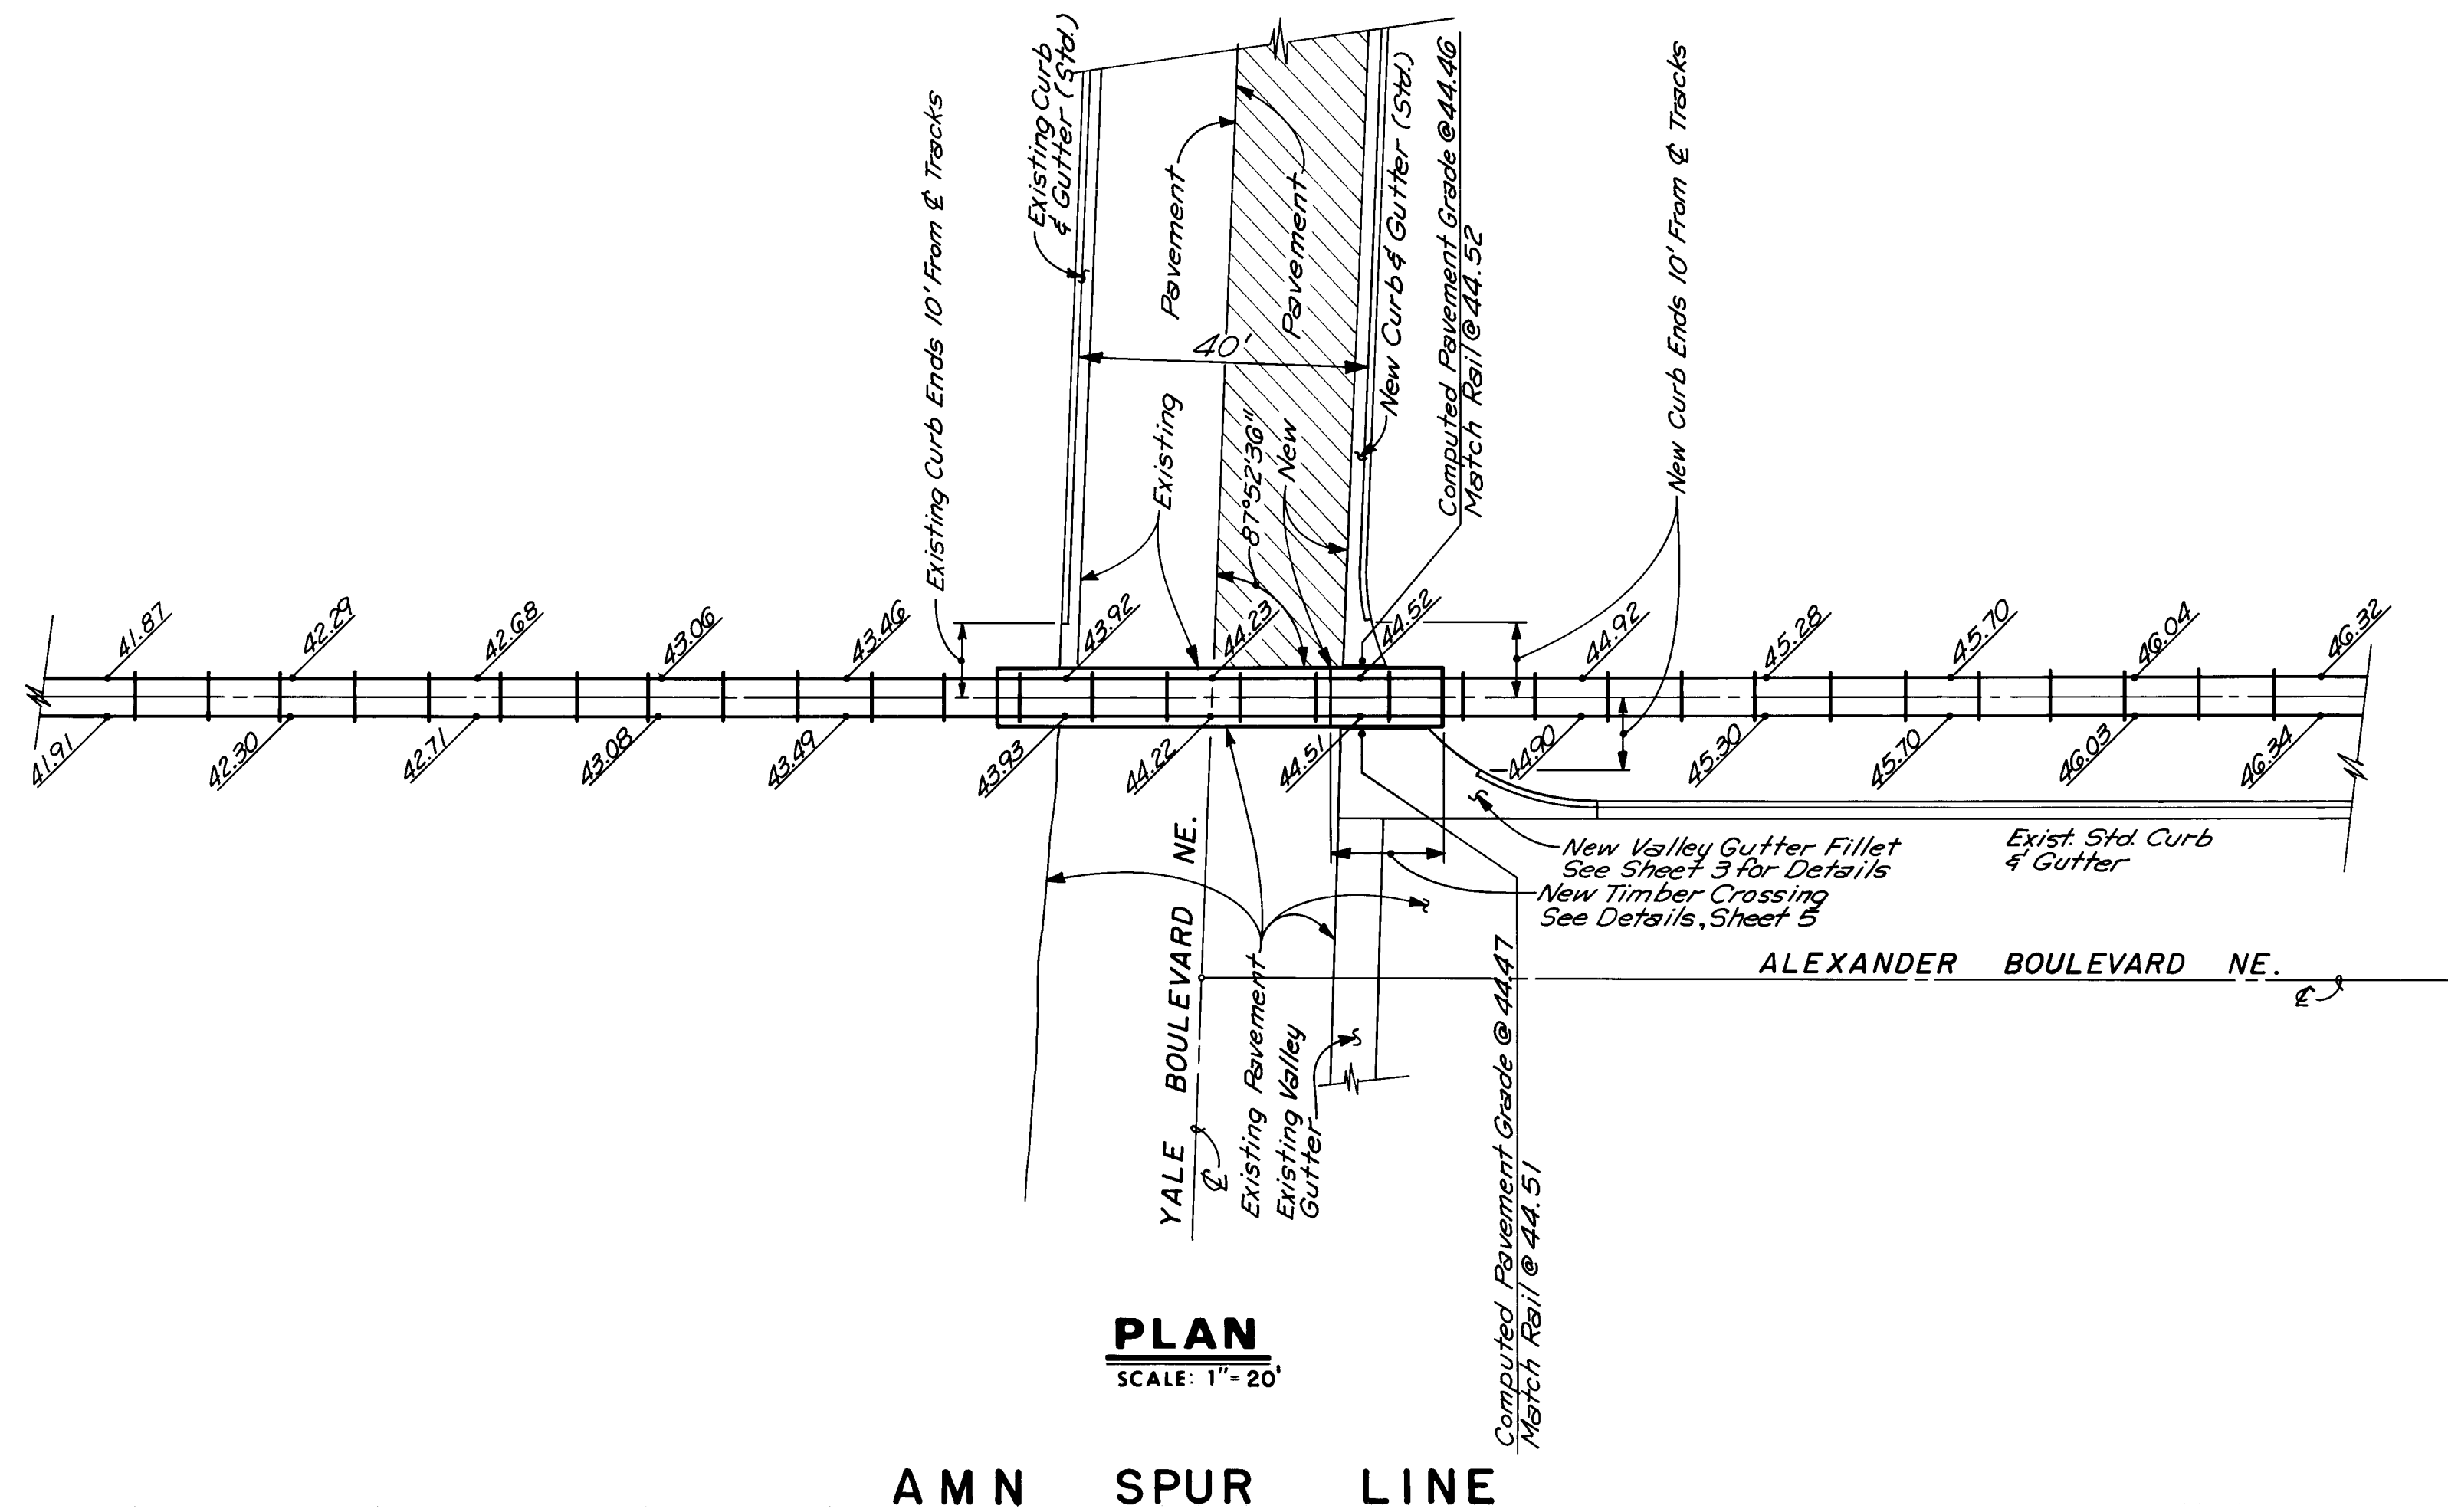

1 2 3 4 5 6 7 8 9 10 11 12
26 37 01 03 90 A

SURVEY INFORMATION			BENCH MARKS			AS BUILT INFORMATION		
FIELD NOTES			NO.			CONSTRUCTION		
BY			DATE			Pride Construction		
NO.			DATE			C.O.A.		
BY			DATE			INSPECTION BY		
NO.			DATE			FIELD		
BY			DATE			CORRECTION BY		
NO.			DATE			MICRO-FILM INFORMATION		
BY			DATE			RECORDED BY		
NO.			DATE			NO.		

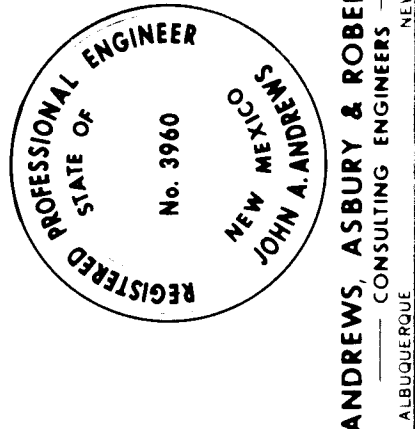



REVISIONS		BY	
NO.		DATE	
DESIGN		DATE	
DESIGNED BY J/M		DATE Sept. 1989	
DRAWN BY T/L		DATE Sept. 1989	
CHECKED BY J/A		DATE Sept. 1989	

CITY OF ALBUQUERQUE
PUBLIC WORKS DEPARTMENT
ENGINEERING GROUP


**YALE BOULEVARD NE.
AND JOAN HILL PLACE NE.
AMN SPUR LINE CROSSING - YALE BOULEVARD NE.**

APPROVALS	ENGINEER	DATE	APPROVALS	ENGINEER	DATE
D.R.C. Chair					
Trans. Dev	R.D. Davis	10-19-89			
Utility Dev					

DRAWING NO. **3701** MAP NO. **G-16** SHEET **3A** OF **7**

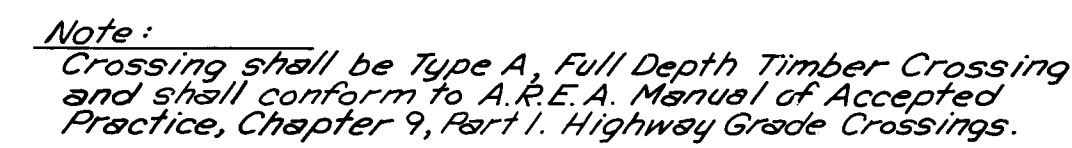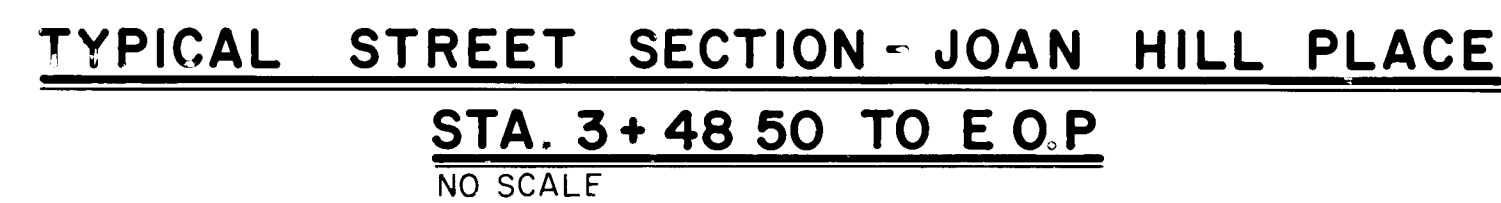


NO SCALE

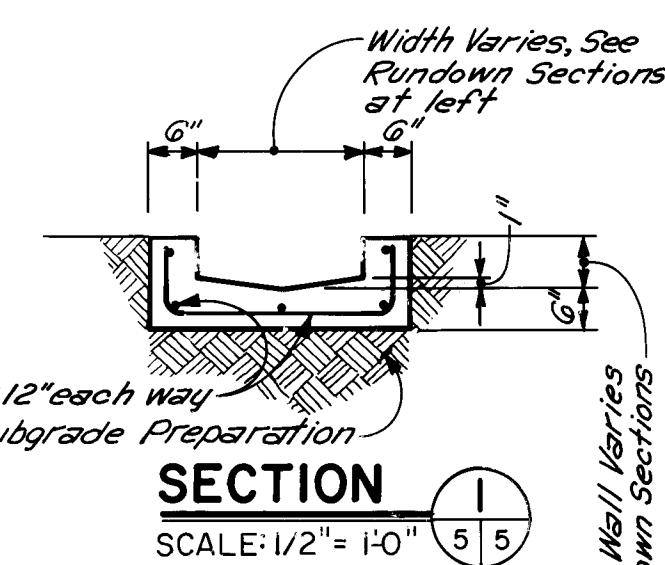[illegible]

CITY OF ALBUQUERQUE					
MUNICIPAL DEVELOPMENT DEPARTMENT					
ENGINEERING DIVISION					
YALE BOULEVARD NE. AND JOAN HILL PLACE NE. STREET SECTIONS & MISCELLANEOUS DETAILS					
APPROVALS	ENGINEER	DATE	APPROVALS	ENGINEER	DATE
City Engineer	<i>Rogel</i>	4/13/88	Liquid Waste	<i>PSGO</i>	4/13/88
A.C.E - Design	"	"	Traffic	<i>Rogel</i>	4/13/88
A.C.E - Hydrology	"	"	Water	<i>PSGO</i>	4/13/88
DRAWING NO.		MAP NO.	SHEET OF		
3701		G-16	5 7		

FINAL	SURVEYED	DATE
NO	PLOTTED	BY
	TEMPLATE	
	AREAS CHECKED	


ORIGINAL	SURVEYED	DATE
NO	PLOTTED	BY
	TEMPLATE	
	AREAS CHECKED	

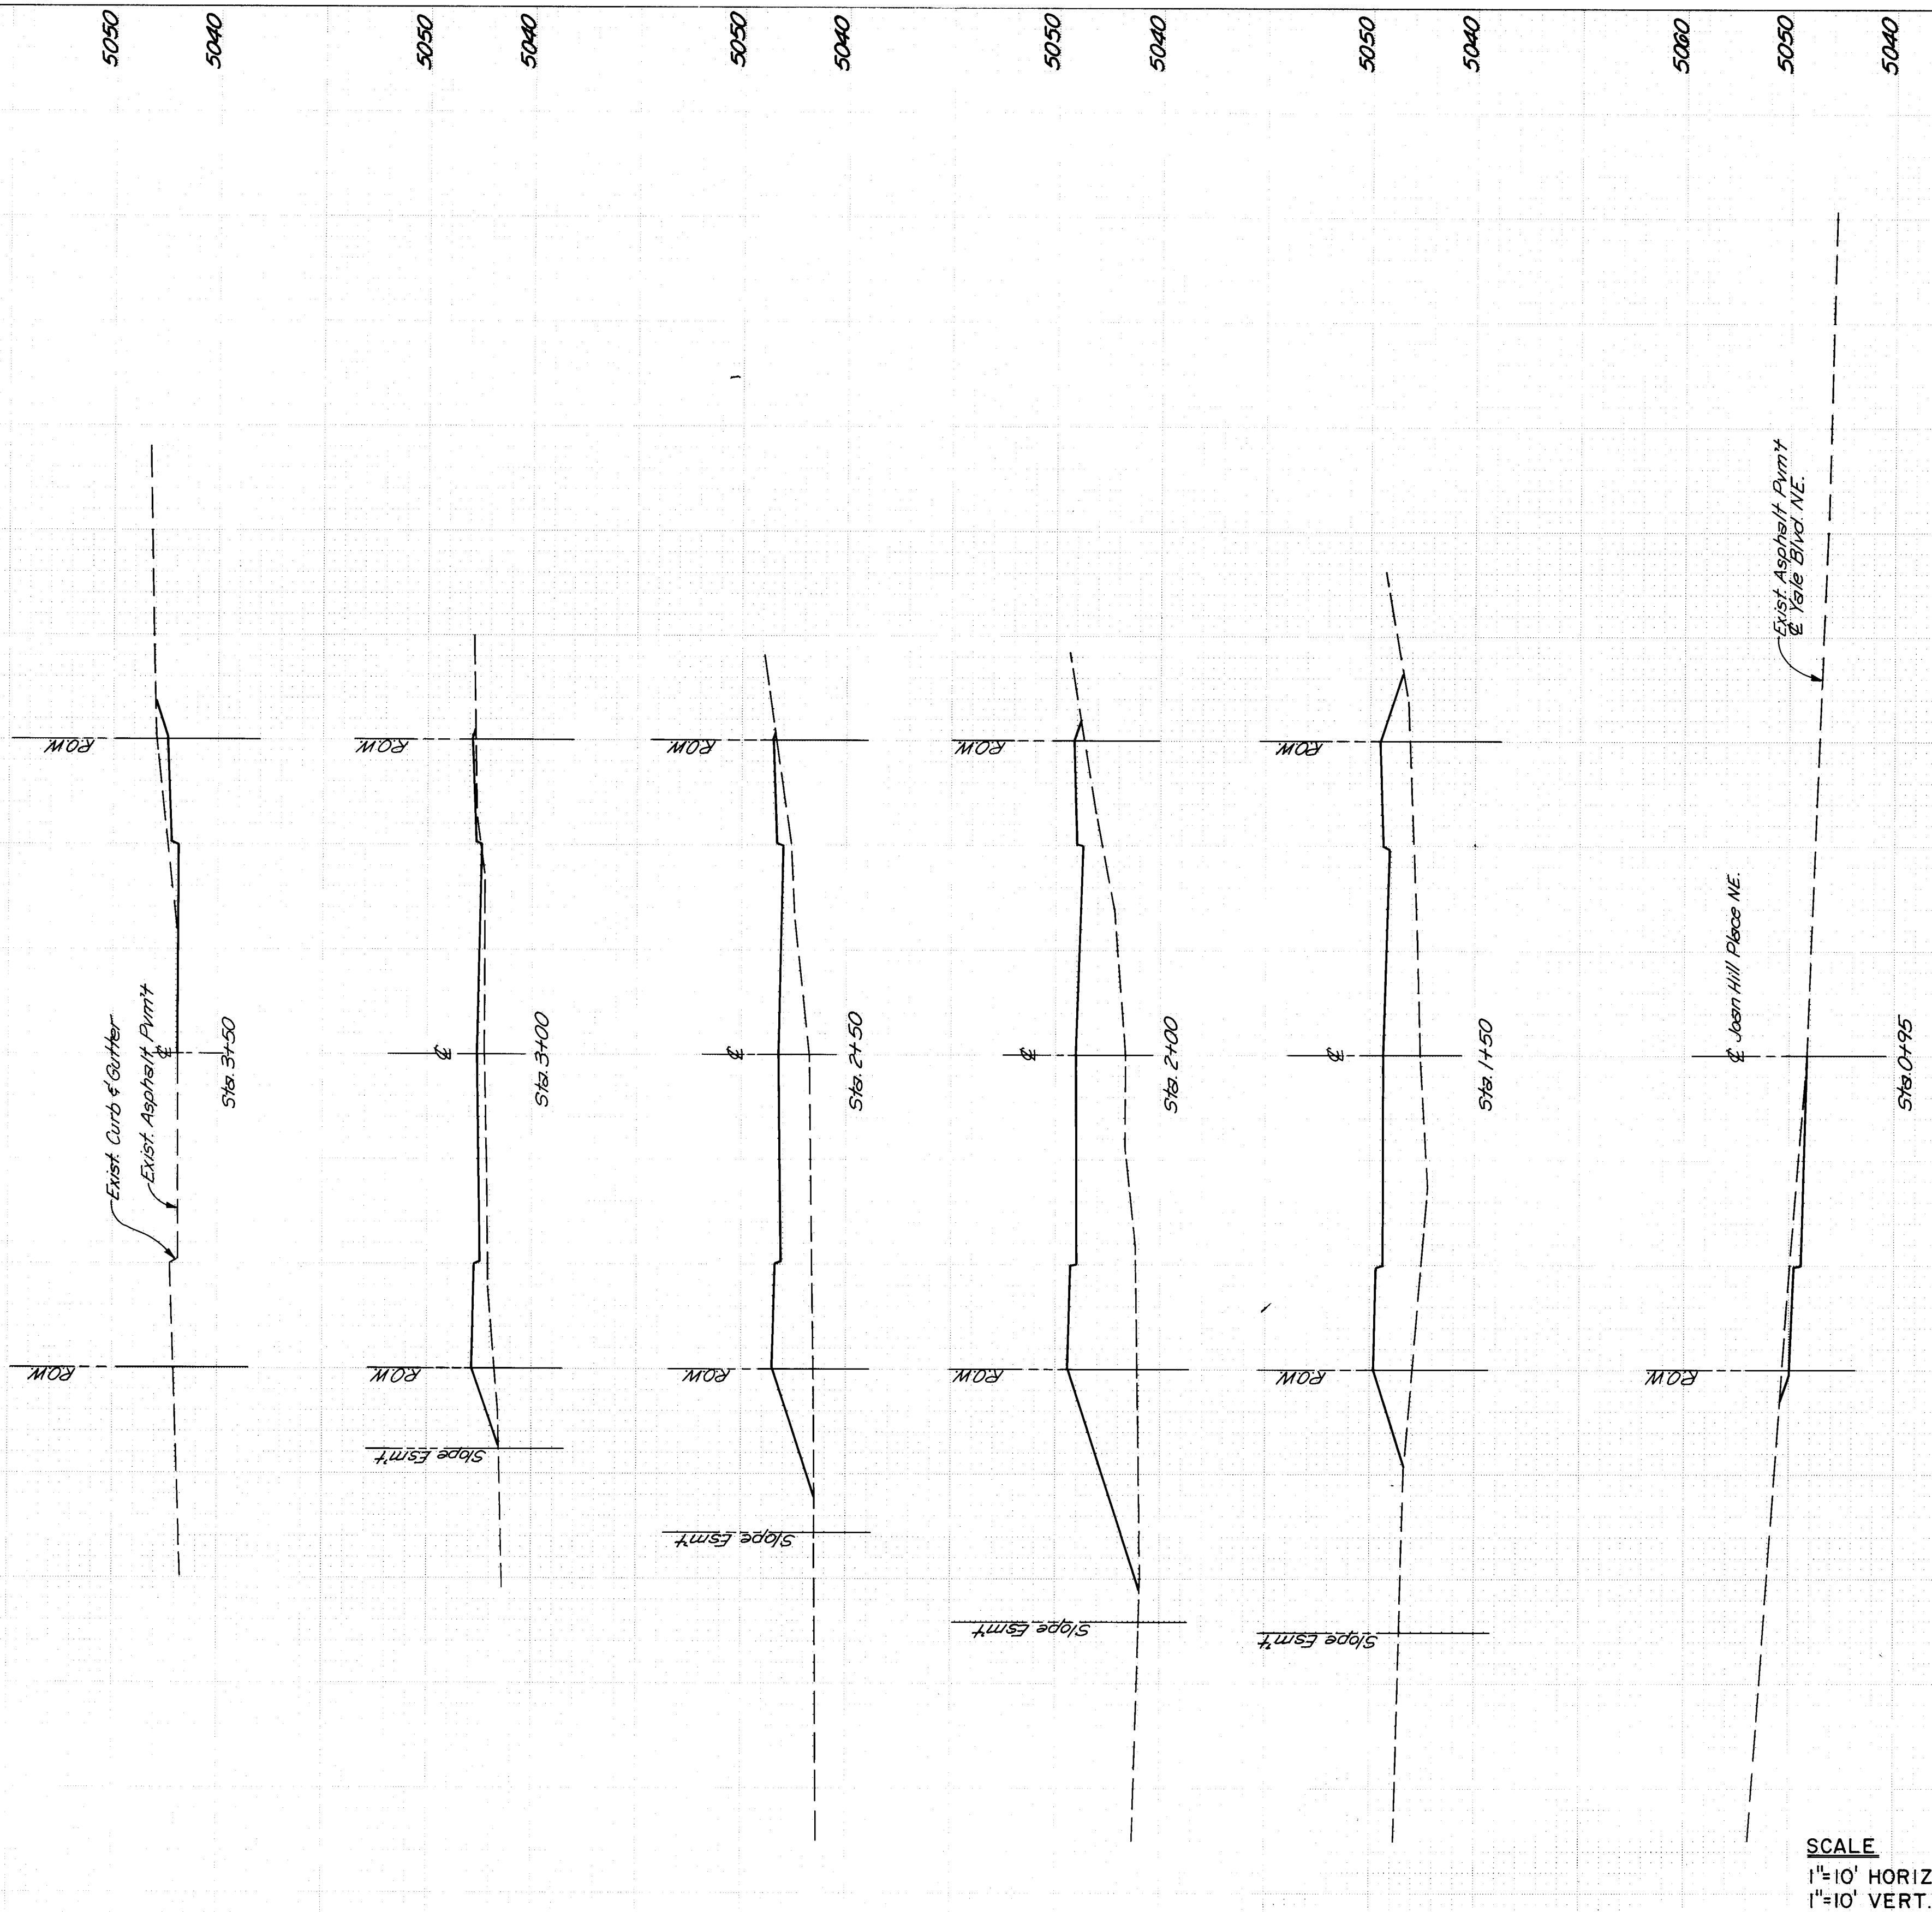

26 370.10690

CITY OF ALBUQUERQUE			
YALE BOULEVARD NE. AND JOAN HILL PLACE NE.			
CROSS SECTIONS - JOAN HILL PLACE NE.			
ANDREWS, ASBURY & ROBERT, INC. CONSULTING ENGINEERS ALBUQUERQUE NEW MEXICO			
FILE NO. 83-347	DRAWN TZ	CHECKED J/M	DATE March 1989
SHEET 6		OF 7	

STREET LIGHTING PLAN

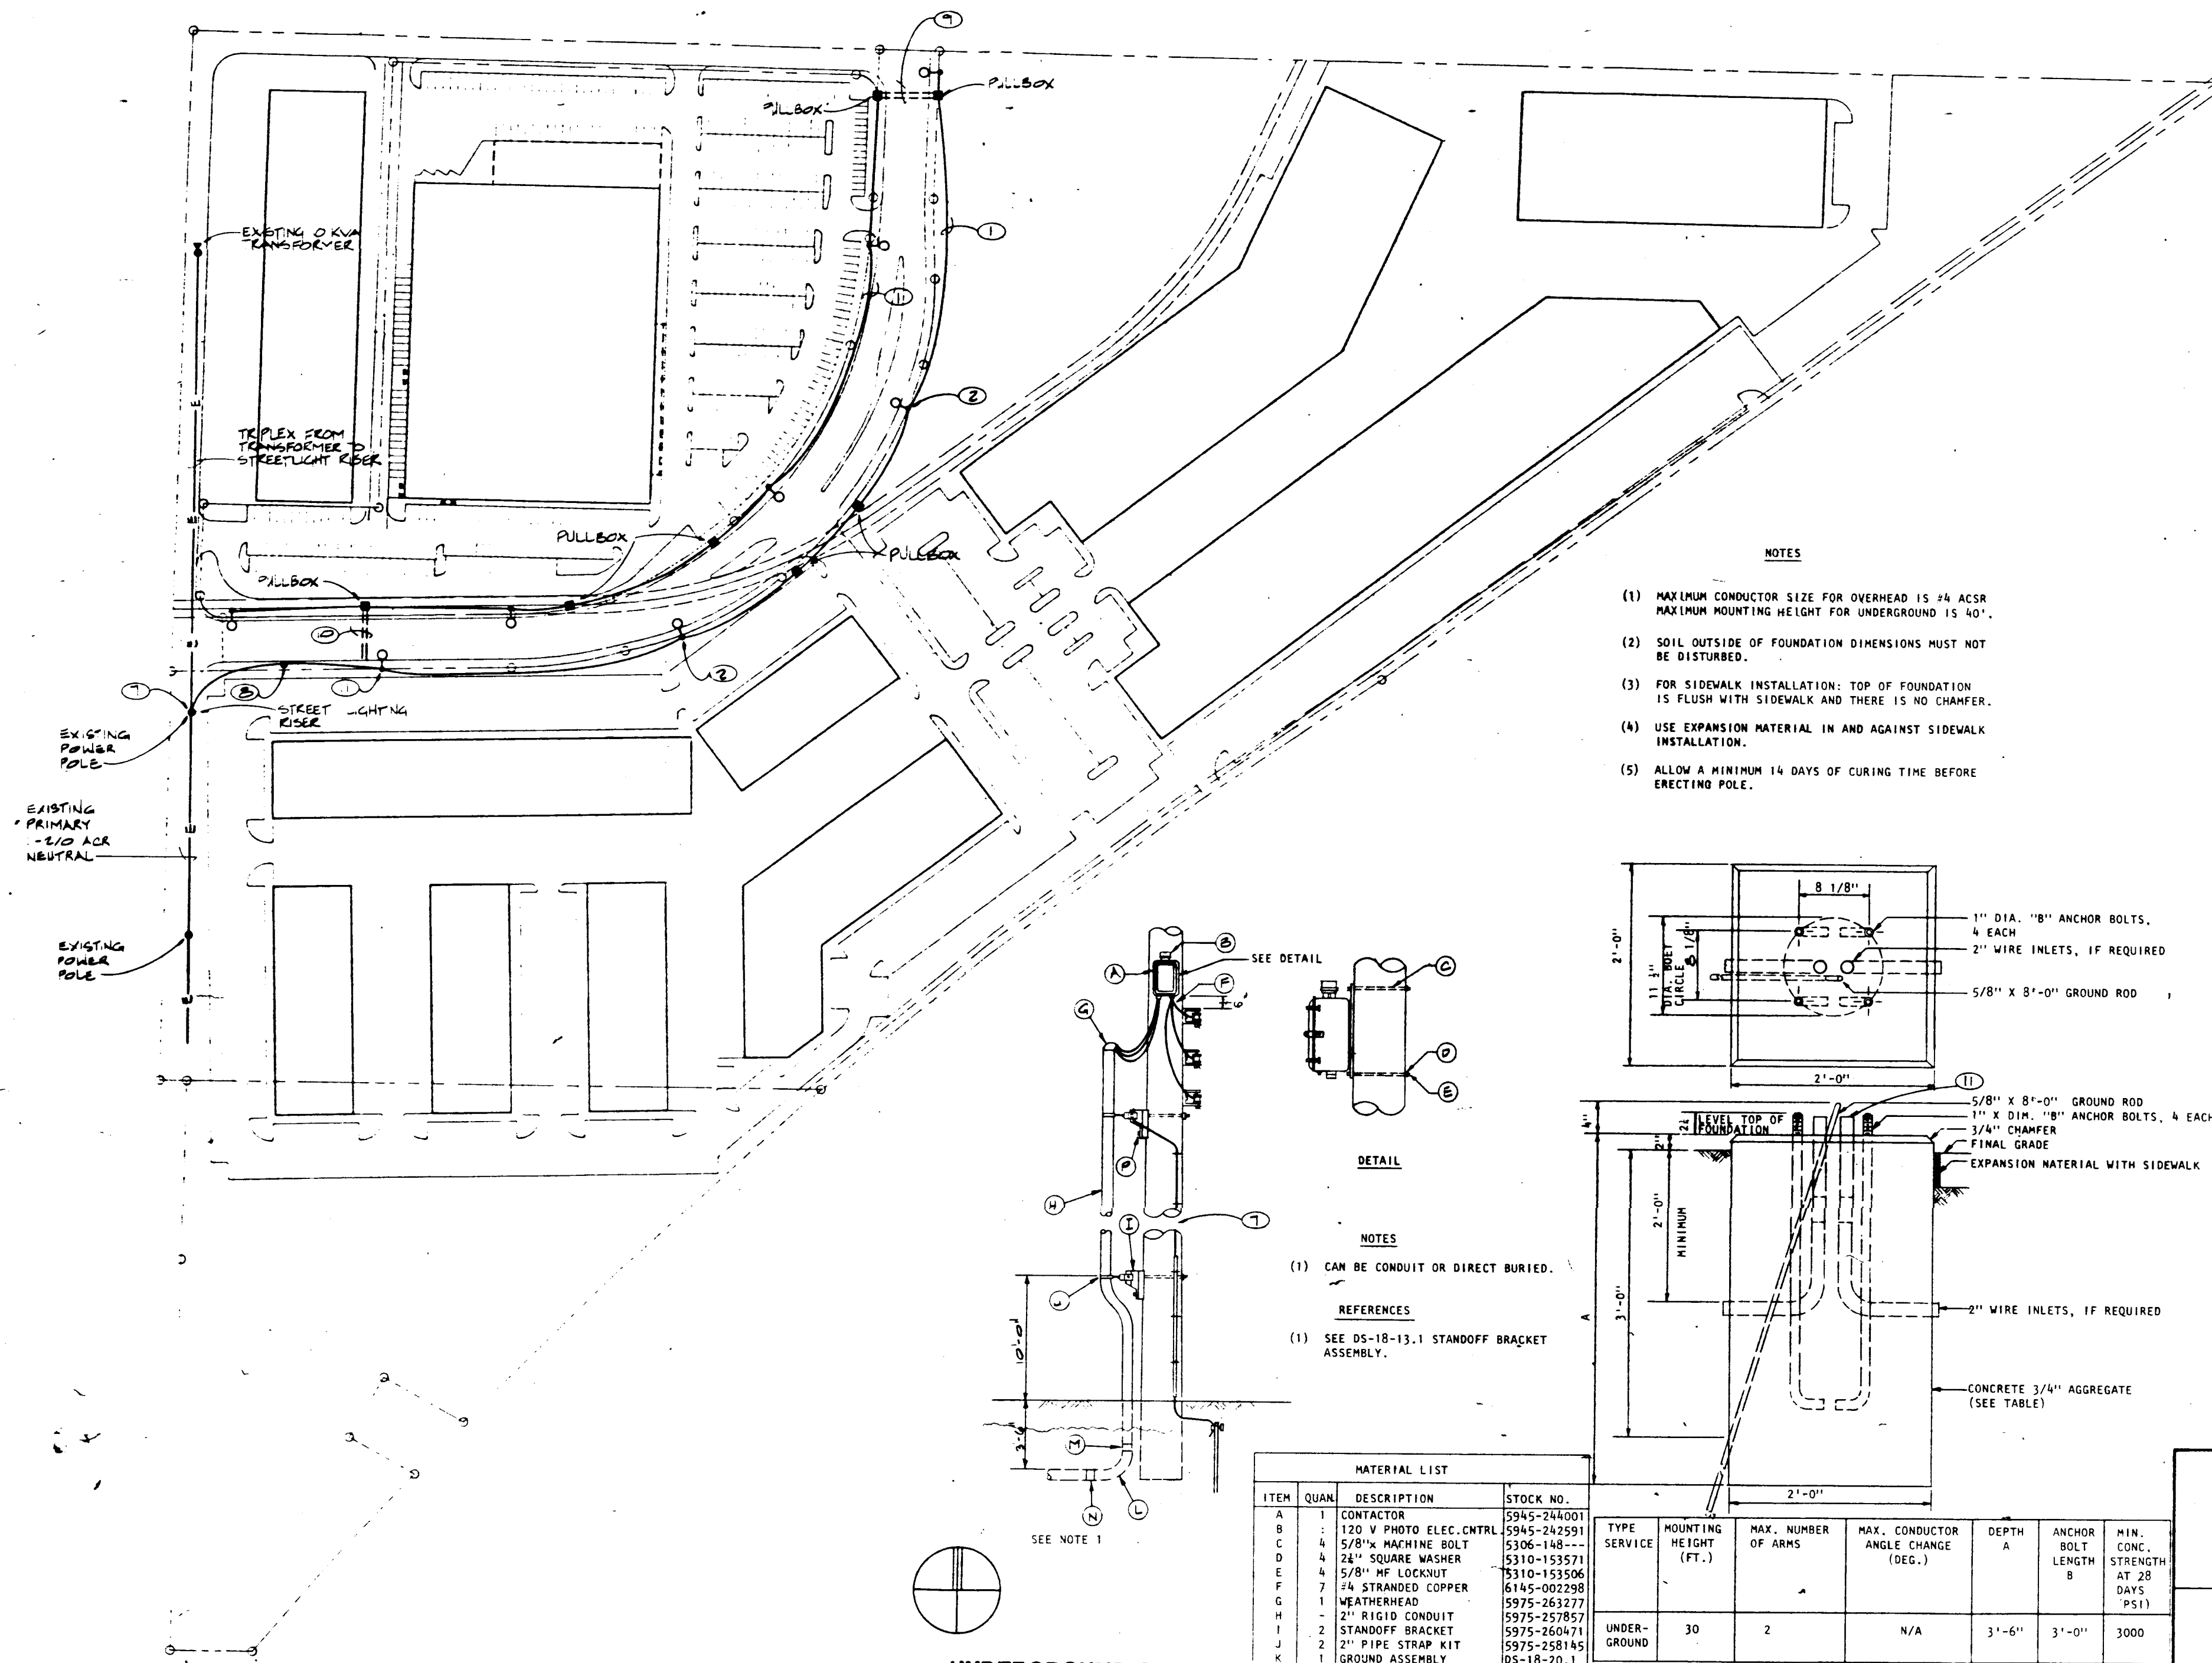


KEYED NOTES

- CONTRACTOR TO INSTALL ALL 2" PVC CONDUIT.
- CONTRACTOR TO POUR BASES AS INDICATED ON P.M. STANDARD #DS-12-14.0 AS SHOWN ON THIS SHEET.
- STREET LIGHTS WILL BE 250 W HPS LIGHTS (240 VOLT) AND ON 28' ALUMINUM POLES. NOT IN THIS CONTRACT IDENTIFYING NUMBER 25.
- WIRE BETWEEN POLES WILL BE TWO (2) CIRCUITS OF #2 ALUMINUM XIP AND WILL BE INSTALLED BY OTHERS.
- PHOTO CONTROLS SHALL BE INSTALLED ON LUMINAIRE BY OTHERS. NIC. THEY SHALL BE POSITIONED TO THE NORTH SO THAT DIRECT SUNLIGHT WILL NOT SHINE ON THE LIGHT SENSITIVE EYE.
- PROPER DATE CODING OF LAMPS AND PHOTO CONTROLS SHALL BE ACCOMPLISHED AT TIME OF INSTALLATION (NOT IN THIS CONTRACT).
- CONTRACTOR TO EXTEND CONDUIT UP EXISTING UNDERGROUND STREET LIGHTING RISER POLE IN ACCORDANCE WITH P.M. DETAIL #DS-12-9.0. TO TERMINATE WITH WEATHER HEAD, STOCK NO. 5975-263277. INCLUDE STAND OFF BRACKETS (+5975-260471), LAG SCREWS (5305-147794) AND 2" PIPE STRAP KIT (+5975-258145).
- CONTRACTOR TO EXTEND 2" CONDUIT TO EXISTING UNDERGROUND RISER POLE.
- AT ONE LOCATION WHERE 2" CONDUIT IS INSTALLED ACROSS ALEXANDER STREET A SECOND 2" CONDUIT SHALL BE INSTALLED IN PARALLEL AND TERMINATING IN PULL BOXES AT BOTH ENDS.
- AT ONE LOCATION WHERE TWO CONDUITS CROSS ALEXANDER, ONE END OF CONDUITS SHALL TERMINATE IN PULLBOX WHILE OTHER TERMINATES IN THE STREET LIGHT FOUNDATION.
- THREE CONDUITS TERMINATE IN THIS STREET LIGHT FOUNDATION.

NOTES

- MAXIMUM CONDUCTOR SIZE FOR OVERHEAD IS #4 ACSR. MAXIMUM MOUNTING HEIGHT FOR UNDERGROUND IS 40'.
- SOIL OUTSIDE OF FOUNDATION DIMENSIONS MUST NOT BE DISTURBED.
- FOR SIDEWALK INSTALLATION: TOP OF FOUNDATION IS FLUSH WITH SIDEWALK AND THERE IS NO CHAMFER.
- USE EXPANSION MATERIAL IN AND AGAINST SIDEWALK INSTALLATION.
- ALLOW A MINIMUM 14 DAYS OF CURING TIME BEFORE ERECTING POLE.

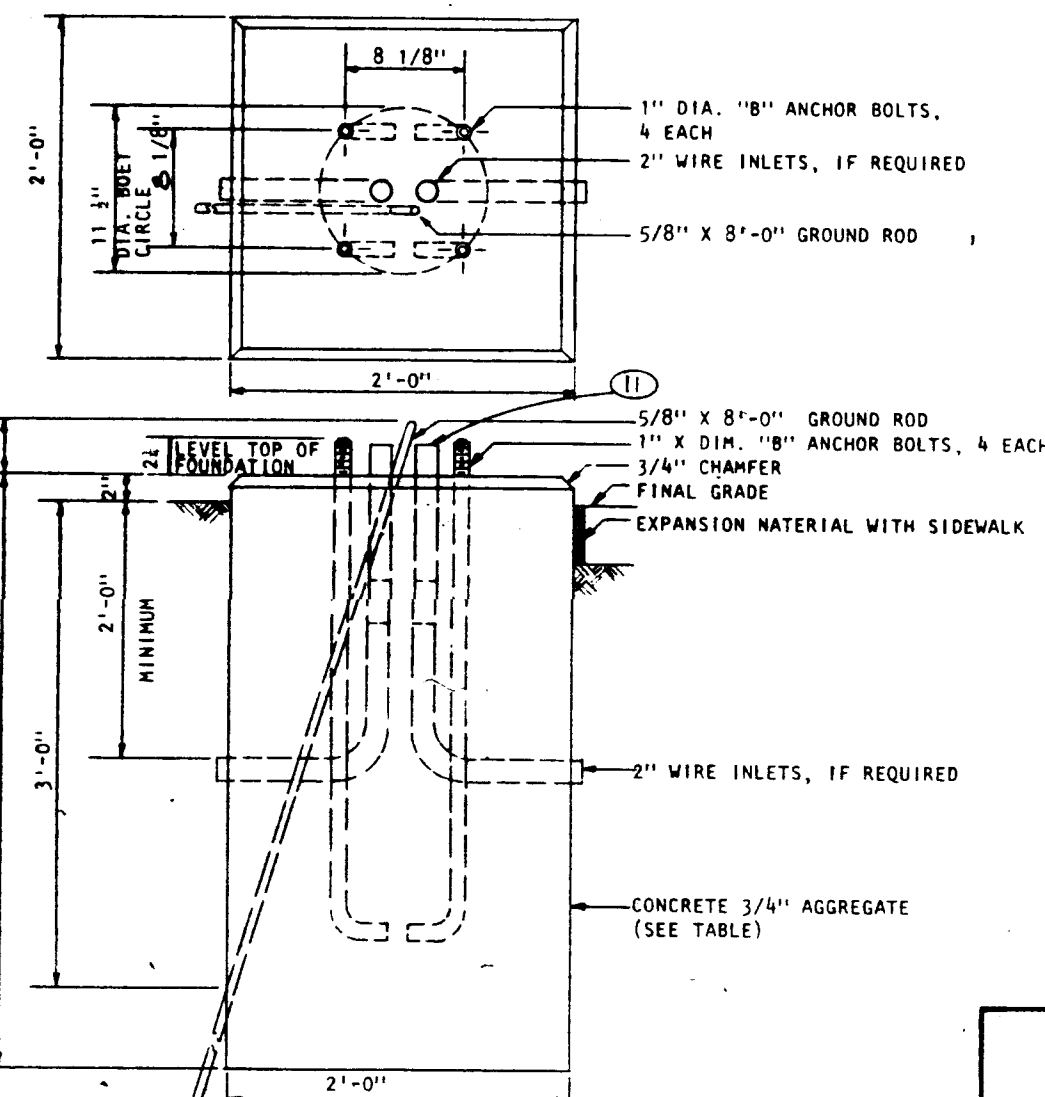

ITEM	QUAN.	DESCRIPTION	STOCK NO.
A	1	CONTRACTOR	5945-24001
B	1	120 V PHOTO ELEC. CNTRL	5945-242591
C	4	5/8" X 1/2" MACHINE BOLT	5306-148---
D	4	24" SQUARE WASHER	5310-133571
E	4	5/8" NF LOCKNUT	5310-133506
F	7	#4 STRANDED COPPER	6145-002298
G	1	WEATHERHEAD	5975-263277
H	1	2" RIGID CONDUIT	5975-257857
I	2	STANDOFF BRACKET	5975-260471
J	2	2" PIPE STRAP KIT	5975-258145
K	1	GROUND ASSEMBLY	05-18-10.1
L	1	2" 90° GALVANIZED ELBOW	5975-259549
M	1	2" GALV. COUPLING	5975-272252
N	1	2" PLASTIC BUSHING	5975-259796
P	2	LAG SCREW	5305-147794
Q	1	LINE TAP	5935---


FOUNDATION DETAIL-ARTERIAL STREETLIGHT

		505/889-0030 4600-C Montano Rd. N.E., Albuquerque, New Mexico 87109	
MIDTOWN OFFICE PLAZA			
DATE: 1/22/88	DRAWN BY: TdB	CHECKED BY: TdB	DESIGNED BY: TdB
SHEET TITLE: STREET LIGHTING PLAN			SHEET NO. E-1

NOTICE TO CONTRACTOR

THIS SHEET IS PROVIDED AS INFORMATION TO P.N.M. ONLY.
NO WORK SHOWN ON THIS SHEET IS TO BE PERFORMED UNDER THIS CONTRACT.

SURVEY INFORMATION		BENCH MARKS		AS BUILT INFORMATION	
NO.	BY	DATE	ACS/NNHS STA. #1-25-20"	CONTRACTOR	DATE
			BRASS TABLET SET IN CONCRETE POST LOCATED ON THE WESTERLY R.O.W. LINE OF I-25, 0.5 MILES SOUTHWESTERLY FROM THE INTERSECTION WITH MONTANO RD. ELEV. 5079.46	WORK DONE BY	DATE
				INSPECTED BY	DATE
				FIELD ACCEPTANCE BY	DATE
				DRAWINGS BY	DATE
				CHECKED BY	DATE
				RECORDED BY	DATE
				NO	

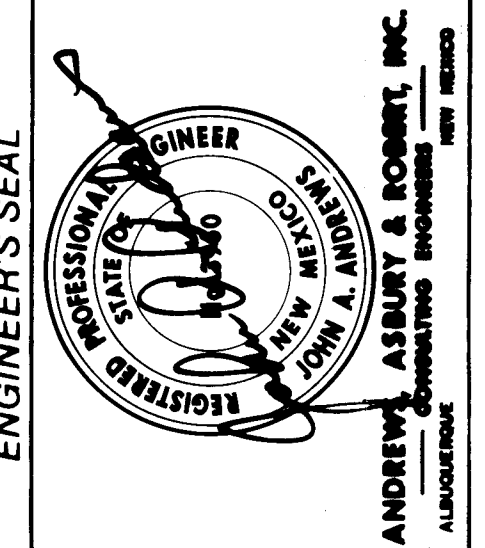

1 2 3 4 5 6 7 8 9 10 11 12
26 37010790

CITY OF ALBUQUERQUE MUNICIPAL DEVELOPMENT DEPARTMENT ENGINEERING DIVISION			
YALE BOULEVARD NE. AND JOAN HILL PLACE NE. STREET LIGHTING PLAN-ALEXANDER BLVD. NE.			
APPROVALS	ENGINEER	DATE	APPROVALS
City Engineer	Rogulha	1/28	Liquid Waste
A.C.E.-Design	"	"	Traffic
A.C.E.-Hydrology	"	"	Water
DRAWING NO. 3701		MAP NO. G-16	
SHEET 7		OF 7	