
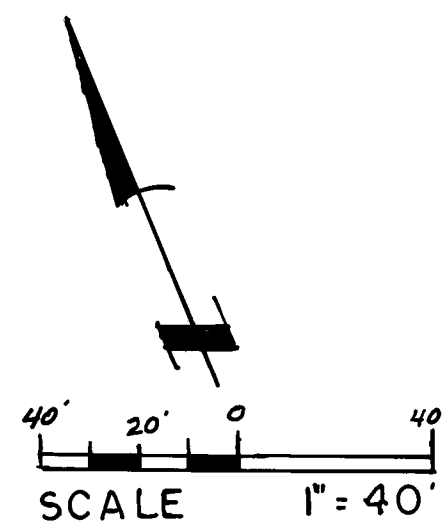


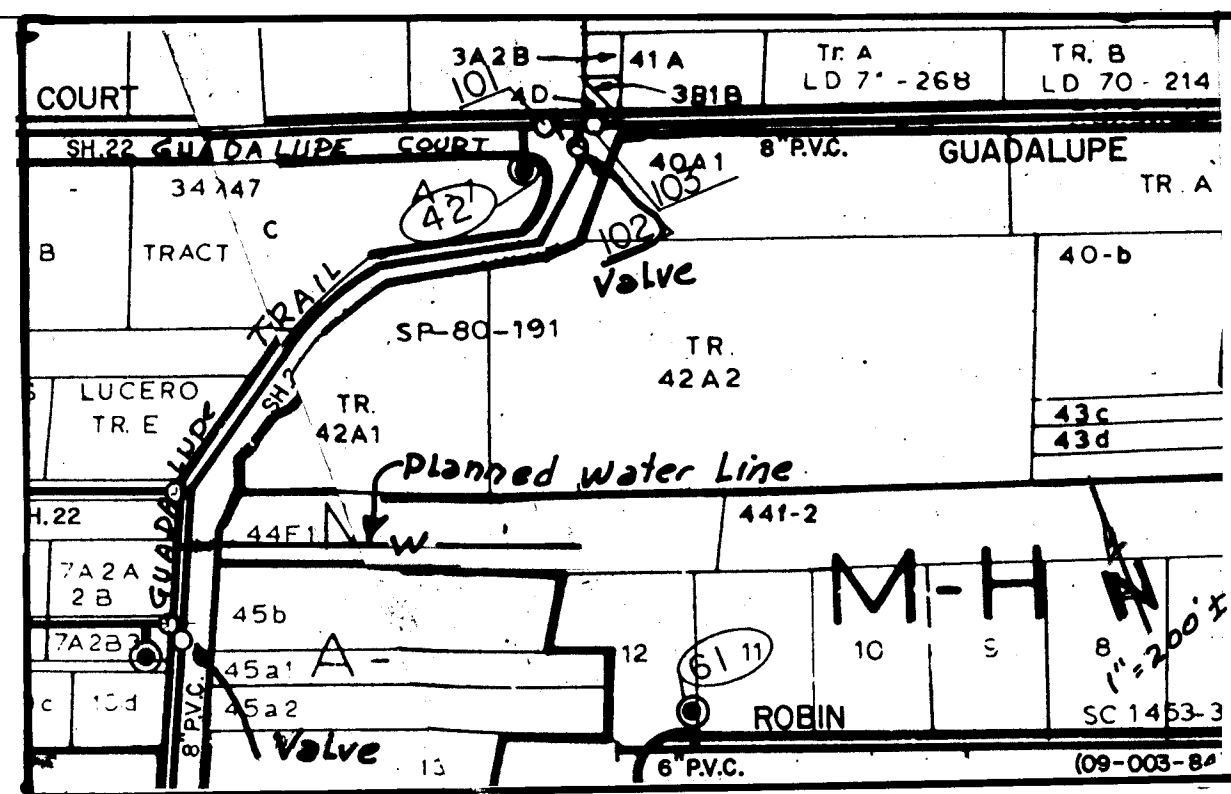

LEGEND

Water Line — W — W —

Gate Valve — X —

Water Service Connection — F —

Fire Hydrant — H —

Cap or Plug — P —


Existing Water Line — - - - W - - -

Existing Gas Line — - - - G - - -


Property Boundary Line — — — — —

Easement Boundary Line — - - - - -

Existing Cable Line — - - - C - - -

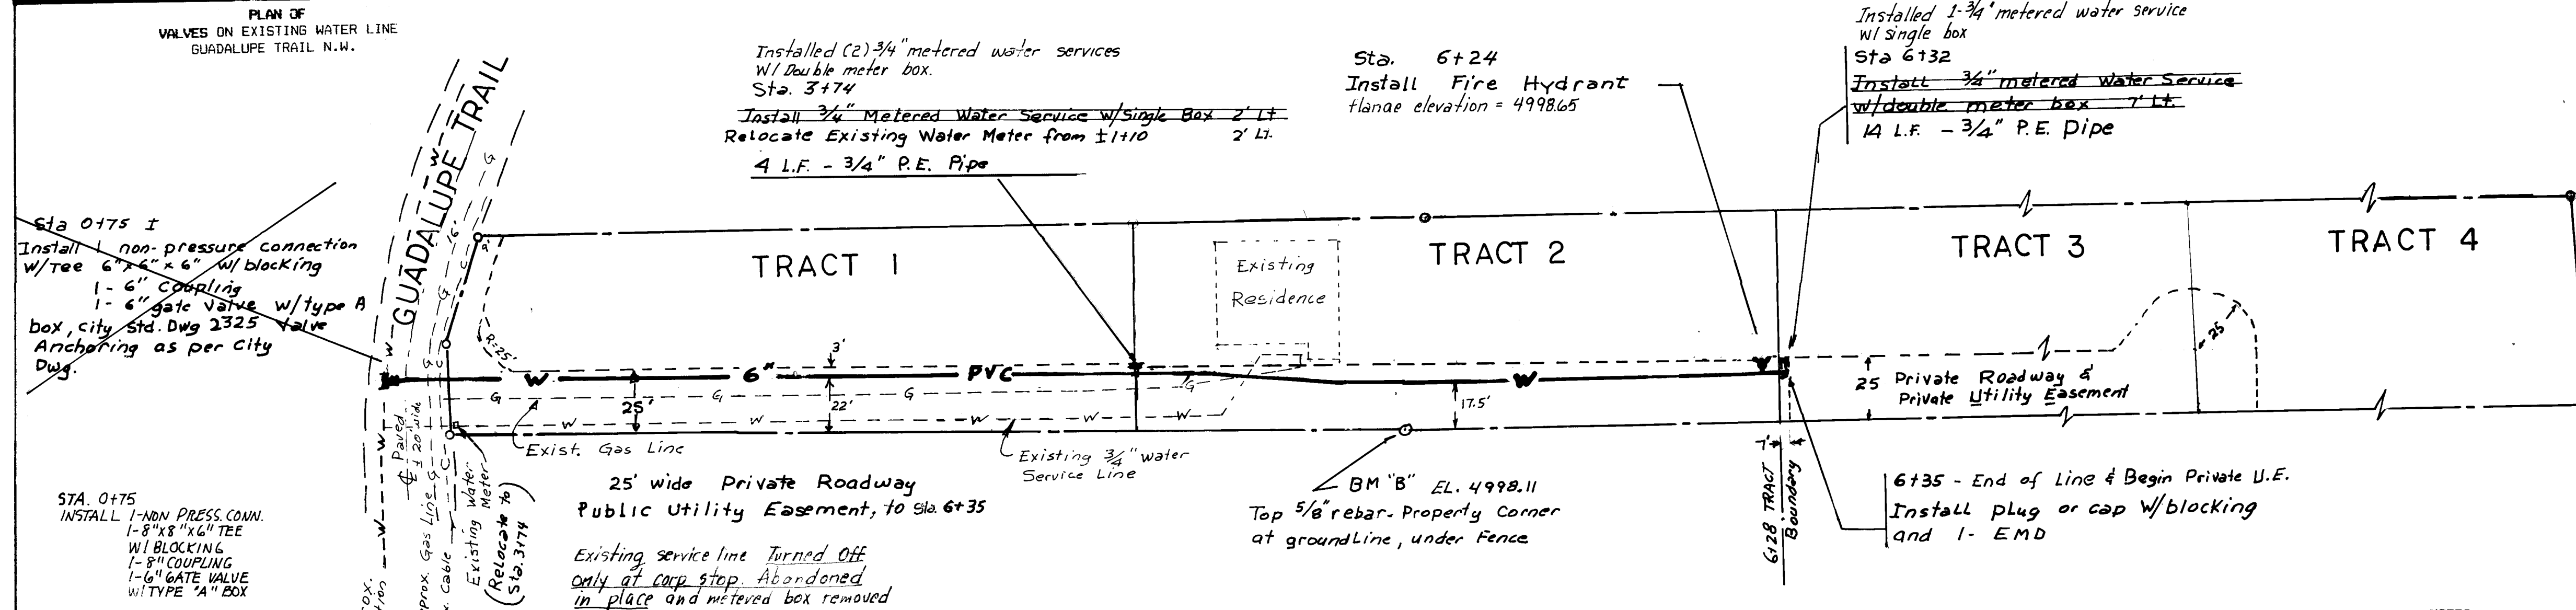

- NOTES**
- The waterline shall have a minimum bury of 3.0 feet below existing ground (roadway).
 - Electronic Marker Disks (EMD) shall be installed at all tees and all service connections as specified in Section 170, of the Standard Specifications.
 - Concrete blocking shall be installed as per City Standard Drawing 2360.
 - All Water Meter Service connections shall be installed as per City Standard Drawing 2362 and Water Meter Box as per Drawing 2366.

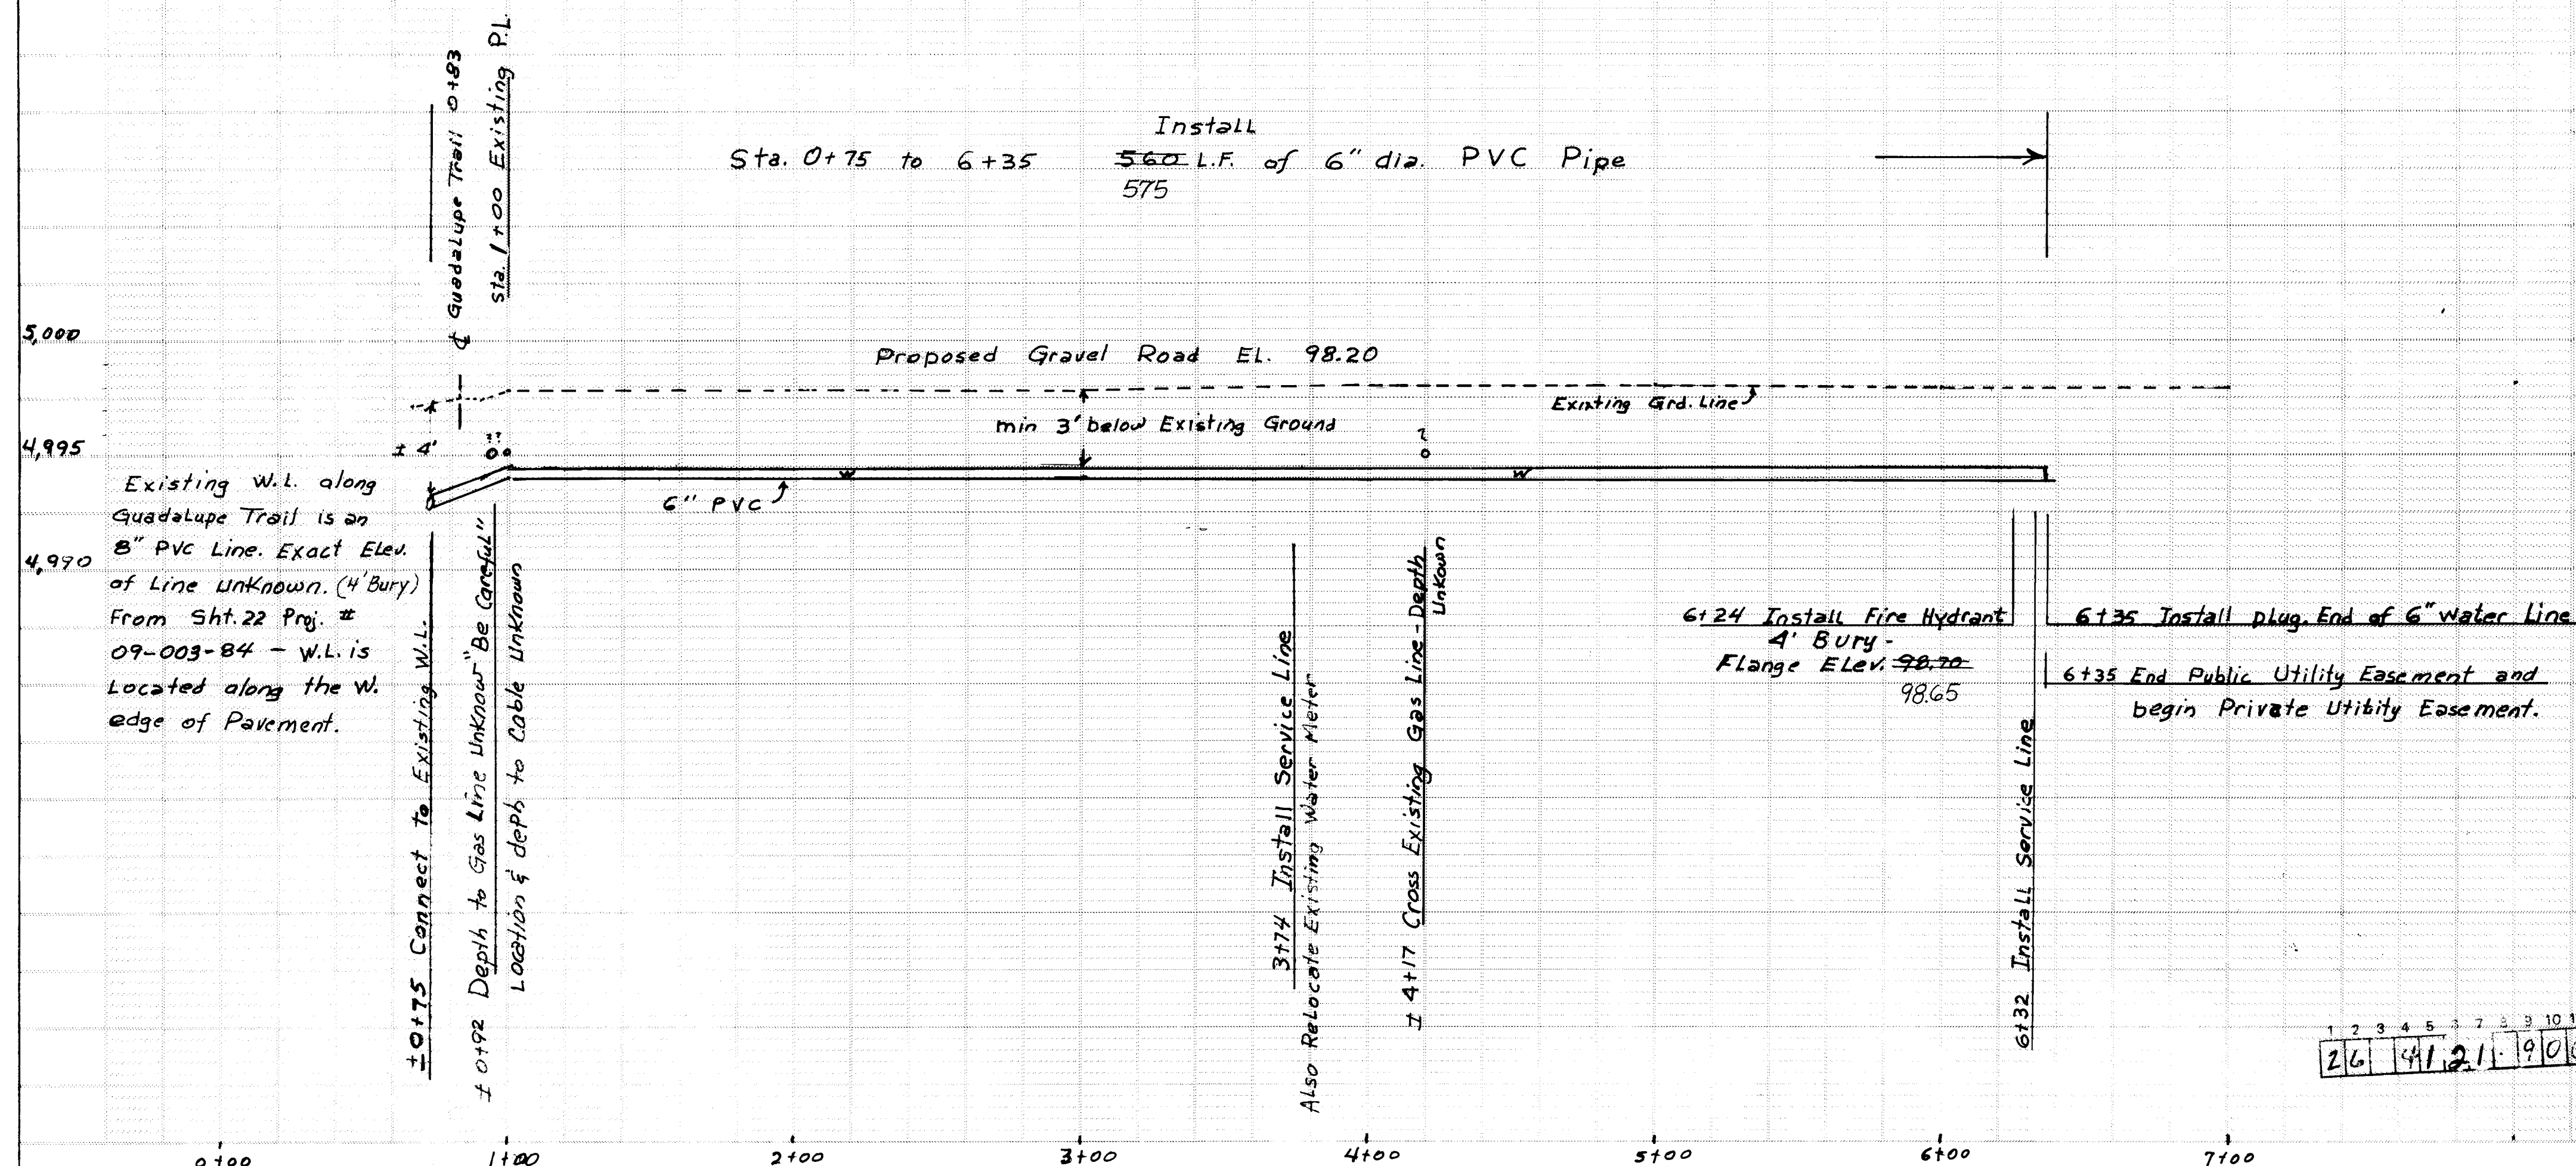

LOCATION MAP
PORTION ZONE ATLAS B-15 & B-16

NOTICE TO CONTRACTOR

- All work detailed on these plans to be performed under contract shall, except as otherwise stated or provided for herein, be constructed in accordance with the City of Albuquerque Standard Specifications for Public Works Construction, 1986.
- Two (2) working days prior to any excavation, contractor must contact New Mexico One-call System, Inc., 260-1998, for location of existing utilities.
- Prior to construction, the contractor shall excavate and verify the horizontal and vertical locations of all obstructions. Should a conflict exist, the contractor shall notify the engineer or surveyor so that the conflict can be resolved with a minimum amount of delay.
- All traffic control or guide signs requiring removal will be directed by the contractor as directed by the engineer. Cost of relocation will be incidental to other pay items.

TRAFFIC CONTROL

Three (3) working days prior to beginning construction the contractor shall submit to the County Traffic Control Section a detailed construction schedule and detour plans for Guadalupe Trail. Two (2) working days prior to construction the contractor shall obtain a barricading permit from County Public Works Department. Contractor shall notify the County Fire Department and the County Sheriff Department prior to occupying the intersection.

THE FOLLOWING NOTES ALSO APPLY

All utilities and utility service lines shall be installed prior to paving.

Trench excavation shall be in accordance with OSHA Ordinances.

Backfill compaction shall be according to Bernalillo County Street Ordinances.

Tack coat requirements shall be determined by the County Engineer.

Three (3) working days prior to construction, contractor shall contact Water Systems (857-8200) for valve shutoff plan.

RIVERA ENGINEERING
2624 Valencia Dr. N.E.
Albuquerque, NM 87110
Phone 881-3419

APPROVAL OF AS BUILT DRAWING
CHIEF CONSTRUCTION ENGINEER
DATE 2/14/91

1 2 3 4 5 6 7 8 9 10 11 12 13 14 15
26 41 21 19 06 19 1

APPROVED FOR
RESTRUCTION
DATE 8-10-90

SCANNED BY
BY LASON

SCALE 1"=40'

AS BUILT INFORMATION		BENCH MARKS		SURVEY INFORMATION		ENGINEER'S SEAL		REVISIONS		DESIGN		DATE		DATE	
NO.	DATE	NO.	DATE	NO.	DATE	NO.	DATE	NO.	DATE	NO.	DATE	NO.	DATE	NO.	DATE
1		1		1		1		1		1		1		1	
2		2		2		2		2		2		2		2	
3		3		3		3		3		3		3		3	
4		4		4		4		4		4		4		4	
5		5		5		5		5		5		5		5	
6		6		6		6		6		6		6		6	
7		7		7		7		7		7		7		7	
8		8		8		8		8		8		8		8	
9		9		9		9		9		9		9		9	
10		10		10		10		10		10		10		10	
11		11		11		11		11		11		11		11	
12		12		12		12		12		12		12		12	
13		13		13		13		13		13		13		13	
14		14		14		14		14		14		14		14	
15		15		15		15		15		15		15		15	

CITY OF ALBUQUERQUE MUNICIPAL DEVELOPMENT DEPARTMENT ENGINEERING DIVISION					
TITLE: LANDS OF JESS PONCE					
PRIVATE WATER LINE PLAN and PROFILE					
APPROVALS	ENGINEER	DATE	APPROVALS	ENGINEER	DATE
D.R.C. Chairman	Rivera	8/14/90	Water	R.W. Kane	8-14-90
Transportation	N/A		Wastewater	R.W. Kane	8-14-90
Hydrology	N/A				
County P.W.	N/A				
PROJECT NO.	4121.90	MAP NO.	B-15 & B-16	SHEET	1 OF 1

SCANNED BY
BY LASON