


CONSTRUCTION PLANS
FOR
SYCAMORE PLAZA
PUBLIC WATER, SANITARY SEWER AND STORM
DRAINAGE IMPROVEMENTS
ALBUQUERQUE, NEW MEXICO

INDEX	
SHEET NUMBER	DESCRIPTION
1	TITLE SHEET
2	PLAT
3	PLAT (NOT USED)
4-5	GRADING PLAN
6	OVERALL WATER AND SANITARY SEWER PLAN
7-11	WATER AND SANITARY SEWER PLAN AND PROFILE
12	STORM DRAIN DETAIL

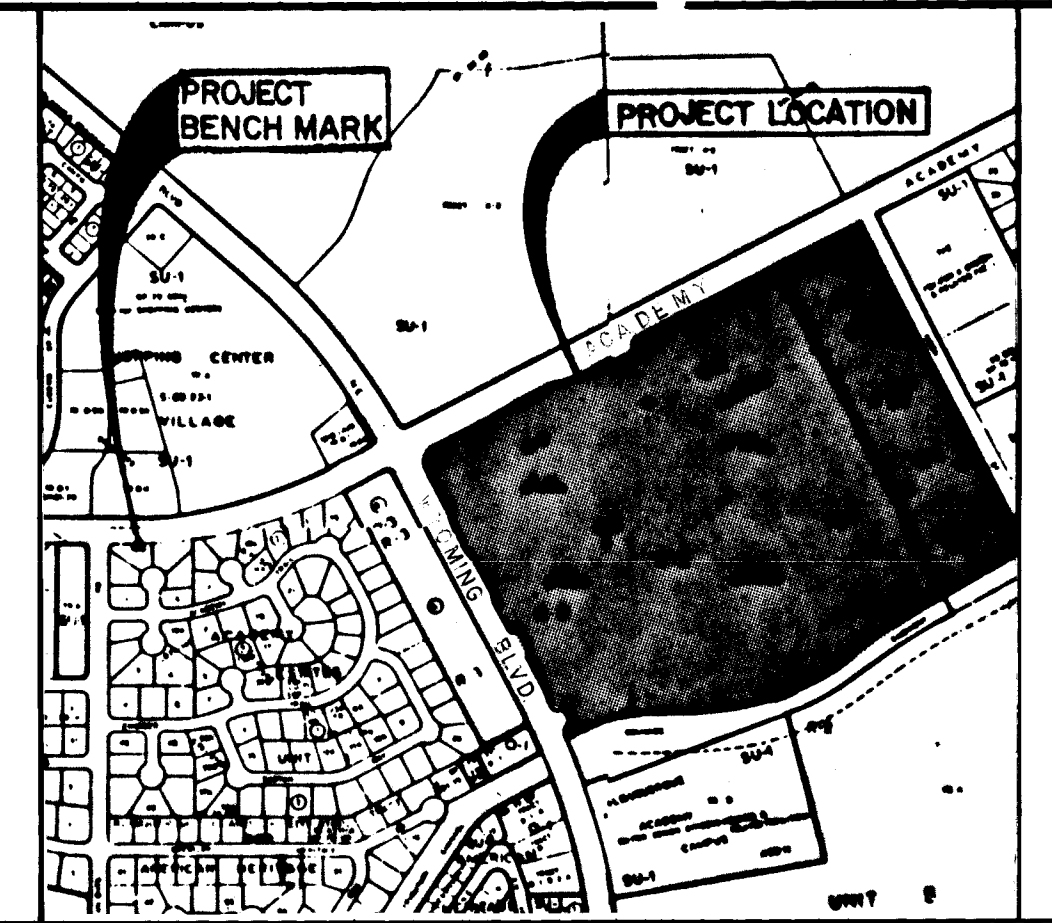


VICINITY MAP
NOT TO SCALE
E&F-19820

NOTICE TO CONTRACTORS

- ALL WORK DETAILED ON THESE PLANS TO BE PERFORMED UNDER CONTRACT SHALL, EXCEPT AS OTHERWISE STATED OR PROVIDED FOR HEREON, BE CONSTRUCTED IN ACCORDANCE WITH THE CITY OF ALBUQUERQUE STANDARD SPECIFICATIONS FOR PUBLIC WORKS CONSTRUCTION, 1986 EDITION.
- TWO WORKING DAYS PRIOR TO ANY EXCAVATION, THE CONTRACTOR MUST CONTACT NEW MEXICO ONE CALL SYSTEM (260-1990) FOR LOCATION OF EXISTING UTILITIES.
- PRIOR TO CONSTRUCTION, THE CONTRACTOR SHALL EXCAVATE AND VERIFY THE HORIZONTAL AND VERTICAL LOCATIONS OF ALL OBSTRUCTIONS. SHOULD A CONFLICT EXIST, THE CONTRACTOR SHALL NOTIFY THE ENGINEER OR SURVEYOR IMMEDIATELY SO THAT THE CONFLICT CAN BE RESOLVED WITH A MINIMUM AMOUNT OF DELAY.
- THREE (3) WORKING DAYS PRIOR TO BEGINNING CONSTRUCTION, THE CONTRACTOR SHALL SUBMIT TO CONSTRUCTION COORDINATION DIVISION A DETAILED CONSTRUCTION SCHEDULE. TWO (2) WORKING DAYS PRIOR TO CONSTRUCTION, THE CONTRACTOR SHALL OBTAIN A BARRICADING PERMIT FROM THE CONST. COORDINATION DIVISION. CONTRACTOR SHALL NOTIFY BARRICADE ENGINEER (768-2551) PRIOR TO OCCUPYING AN INTERSECTION. REFER TO SECTION 19 OF THE GENERAL CONDITIONS OF THE STANDARD SPECIFICATIONS.
- ALL STREET STRIPING ALTERED OR DESTROYED SHALL BE REPLACED IN KIND BY CONTRACTOR TO LOCATION AND IN KIND AS EXISTING OR AS INDICATED BY THIS PLAN SET.
- CONTRACTOR SHALL NOTIFY THE ENGINEER NOT LESS THAN SEVEN (7) DAYS PRIOR TO STARTING WORK IN ORDER THAT THE ENGINEER MAY TAKE NECESSARY MEASURES TO INSURE THE PRESERVATION OF SURVEY MONUMENTS. CONTRACTOR SHALL NOT DISTURB PERMANENT SURVEY MONUMENTS WITHOUT THE CONSENT OF THE ENGINEER AND SHALL NOTIFY THE ENGINEER AND BEAR THE EXPENSE OF REPLACING ANY THAT MAY BE DISTURBED WITHOUT PERMISSION. REPLACEMENT SHALL BE DONE ONLY BY THE ENGINEER. WHEN A CHANGE IS MADE IN THE FINISHED ELEVATIONS OF THE PAVEMENT OF ANY ROADWAY IN WHICH A PERMANENT SURVEY MONUMENT IS LOCATED, CONTRACTOR SHALL, AT HIS OWN EXPENSE, ADJUST THE MONUMENT COVER TO THE NEW GRADE UNLESS OTHERWISE SPECIFIED. REFER TO SECTION 4.4 OF THE GENERAL CONDITIONS OF THE STANDARD SPECIFICATIONS.


THE FOLLOWING NOTES ALSO APPLY WHEN CHECKED

- ☒ ALL UTILITIES AND UTILITY SERVICE LINES SHALL BE INSTALLED PRIOR TO PAVING.
- ☐ BACKFILL COMPACTION SHALL BE ACCORDING TO SPECIFIED STREET USE.
- ☐ TACK COAT REQUIREMENTS SHALL BE DETERMINED BY THE CITY ENGINEER.
- ☒ SIDEWALKS AND WHEELCHAIR RAMPS WITHIN THE CURB RETURNS SHALL BE CONSTRUCTED WHEREVER A NEW CURB RETURN IS CONSTRUCTED.
- ☒ IF CURB IS DEPRESSED FOR A DRIVEPAD, THE DRIVEPAD SHALL BE CONSTRUCTED PRIOR TO ACCEPTANCE OF CURB AND GUTTER.
- ☒ ALL STORM DRAINAGE FACILITIES SHALL BE COMPLETED PRIOR TO FINAL ACCEPTANCE.
- ☒ THE REQUESTOR OR DEVELOPER SHALL BE RESPONSIBLE FOR REPAIR OR REPLACEMENT OF ALL CURB AND GUTTER OR SIDEWALK DAMAGED AFTER APPROVAL BY THE CITY ENGINEER OF WORK COMPLETED BY THE CONTRACTOR.

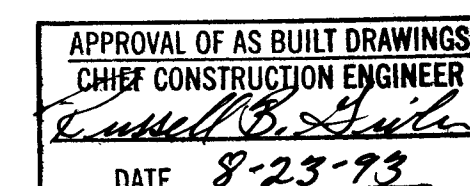

1 2 3 4 5 6 7 8 9 10 11 12 13 14 15
26 4555.900193

AN: (CONTINUED ON ONLY)

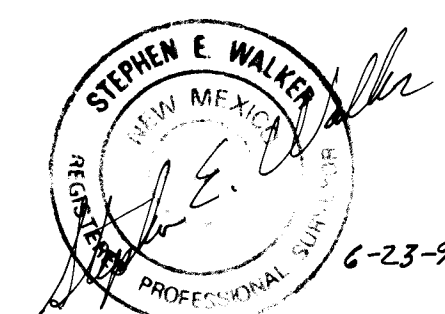

REV	SHEETS	CITY/ENGINEER	DATE	USER DEPARTMENT	DATE	USER DEPARTMENT	DATE
1	1	R.W. Kame	2-10-93	3-10-93	3-10-93		


APPROVAL OF REVISIONS

	BOHANNAN HUSTON INC. ALBUQUERQUE, NEW MEXICO ENGINEERS PLANNERS PHOTOGRAMMETRISTS	APPROVED FOR CONSTRUCTION Russell B. G. G. G. 1-14-93 C.E.
PROJECT NUMBER 4555.90		SHEET 1 OF 12


BH1 JOB NO. 91249.41

2 of 12


- NOTE -
PER GEORGE KING -
SHEET # 26 4555 900393
NOT MISSING. PROJECT
SHEETS WERE NOT NUMBERED
CORRECTLY.

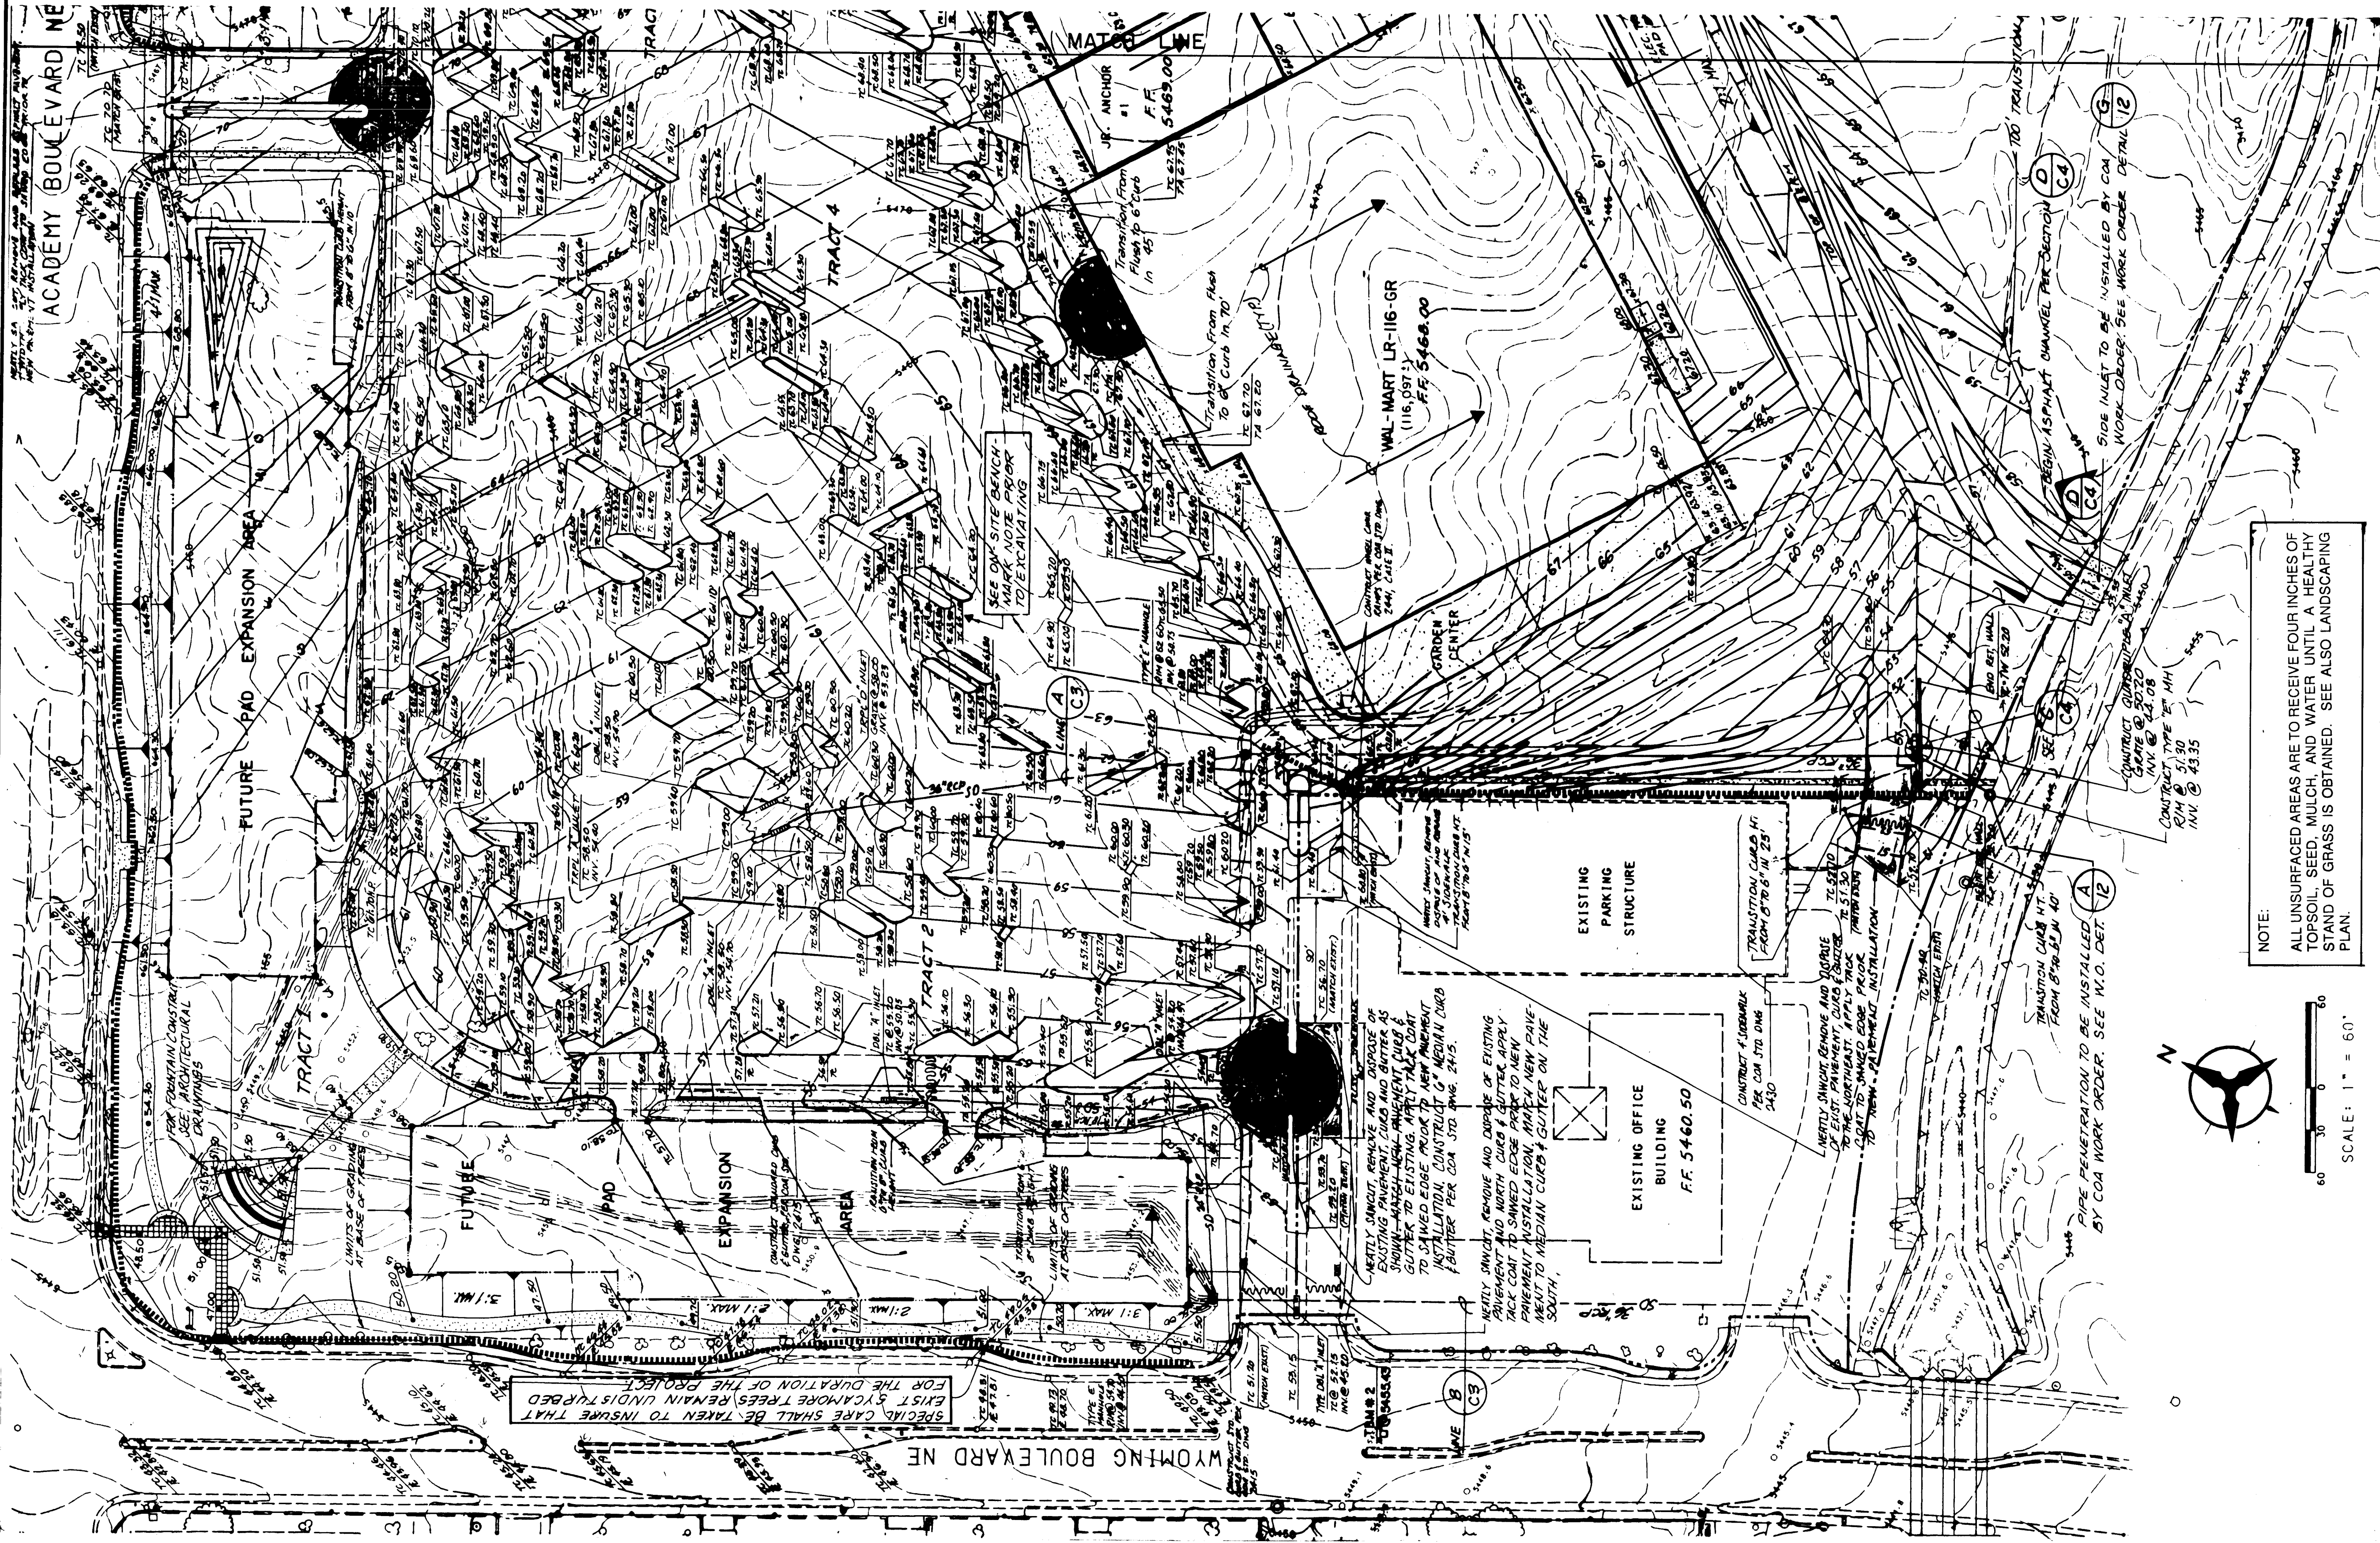

NOTE:
ALL UNSURFACED AREAS ARE TO RECEIVE FOUR INCHES OF TOPSOIL, SEED, MULCH, AND WATER UNTIL A HEALTHY STAND OF GRASS IS OBTAINED. SEE ALSO LANDSCAPING PLAN.

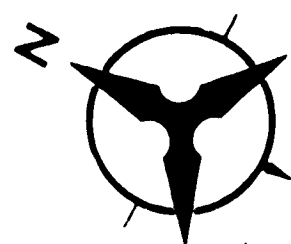

SCALE: 1" = 60'

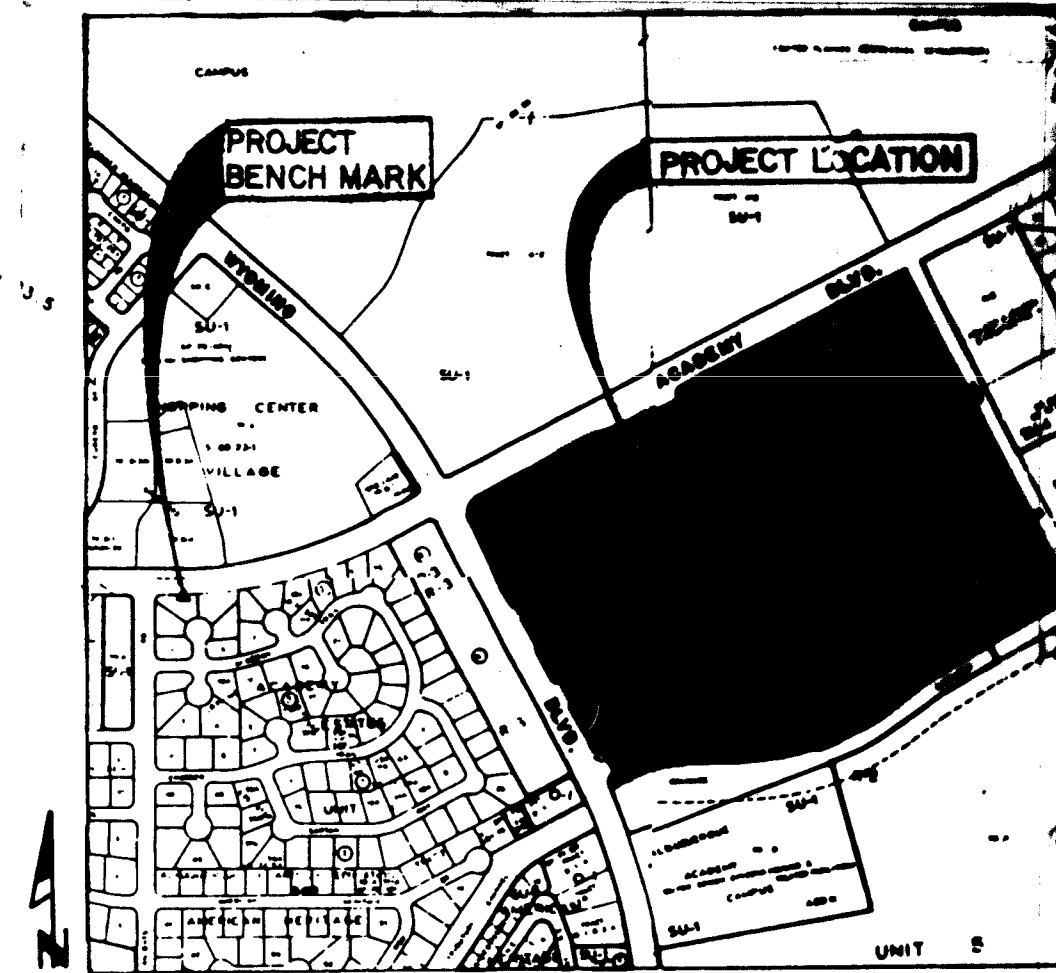

THIS GRADING PLAN IS FOR INFORMATION ONLY

LEGEND

- FUTURE EXPANSION
- GRADE BREAK
- EXISTING SPOT ELEVATION
- PROPOSED SPOT ELEVATION
- EXISTING CONTOUR
- PROPOSED CONTOUR
- EXISTING STORM DRAIN MANHOLE
- PROPOSED STORM DRAIN MANHOLE
- EXISTING STORM DRAIN INLET
- PROPOSED STORM DRAIN INLET
- EDGE OF ASPHALT
- WATER BLOCK
- RETAINING WALL
- ROOF DRAINAGE DIRECTION
- ACCENT PAVEMENT
- FLOW DIRECTION
- CONCRETE PAVEMENT
- EROSION CONTROL BERM
- SLOPED AREA

PROJECT BENCH MARKS

A STANDARD ACS BRASS TABLET STAMPED "12-F19 1978" SET IN TOP OF A CONCRETE POST FLUSH WITH GROUND, LOCATED 217.5' EAST OF THE CENTERLINE OF KNIGHT'S ROAD N.E. AND 6' SOUTH OF THE BACK OF CURB OF ACADEMY ROAD N.E.
ELEVATION 5412.82

TEMPORARY BENCHMARKS

- A "□" SCORED IN THE TOP OF CURB AT THE N.E. P.T. OF THE EAST CURB RETURN OF THE ACCESS ROAD INTO SYCAMORE PLAZA FROM ACADEMY.
ELEVATION 5472.45
- A "□" SCORED IN THE TOP OF CURB AT THE S.W. P.T. OF THE SOUTH CURB RETURN OF THE NORTH ACCESS ROAD INTO SYCAMORE PLAZA FROM WYOMING.
ELEVATION 5455.43

APPROVED FOR ROUGH GRADING (± 1')

HYDROLOGY ENGINEER DATE

NO.	DATE	REMARKS	BY
REVISIONS			

JOB TITLE:
SYCAMORE PLAZA

SHEET TITLE:
INTERIM DRAINAGE AND GRADING PLAN





BOHANNAN-HUSTON, INC.
7800 JEFFERSON NE
ALBUQUERQUE, NM 87109



SHEET
4
OF
12

1 2 3 4 5 6 7 8 9 10 11 12 13 14 15
26 4555.900493

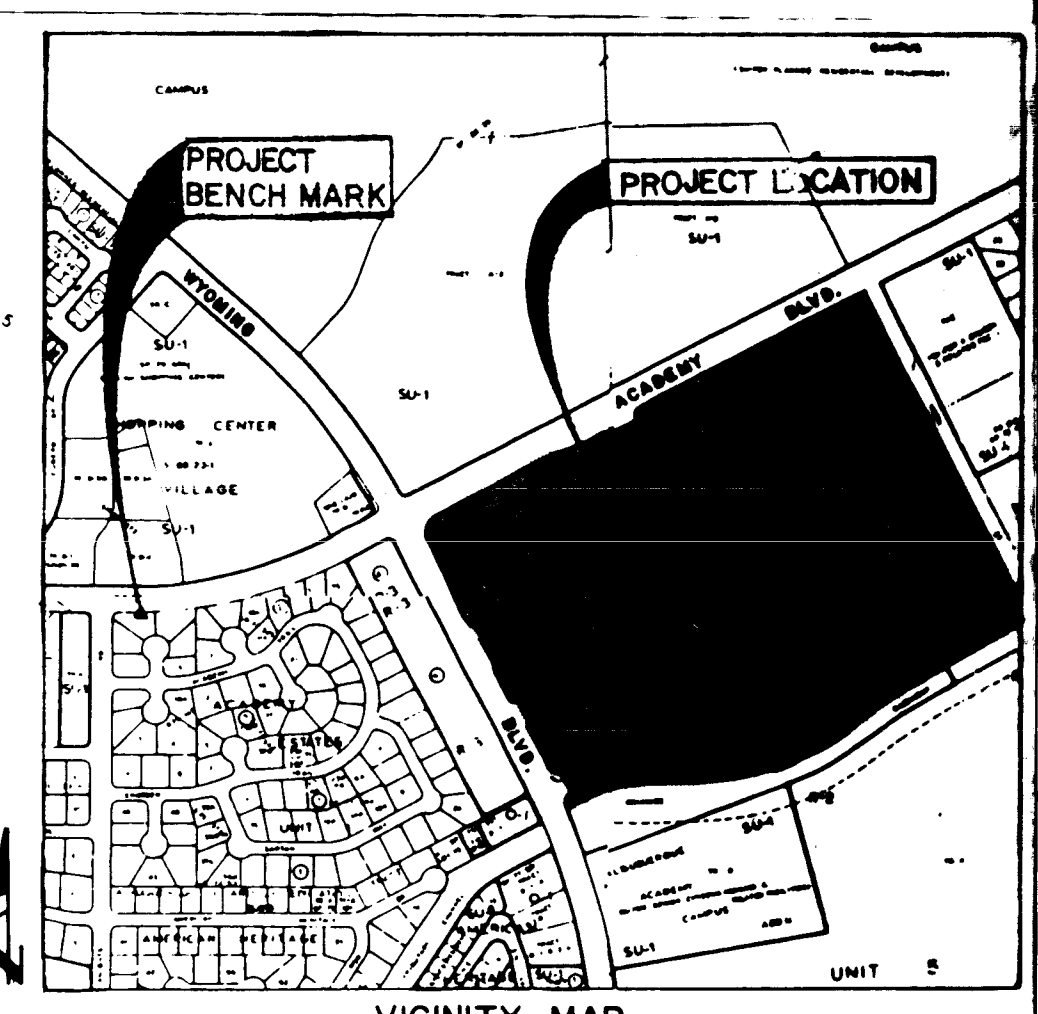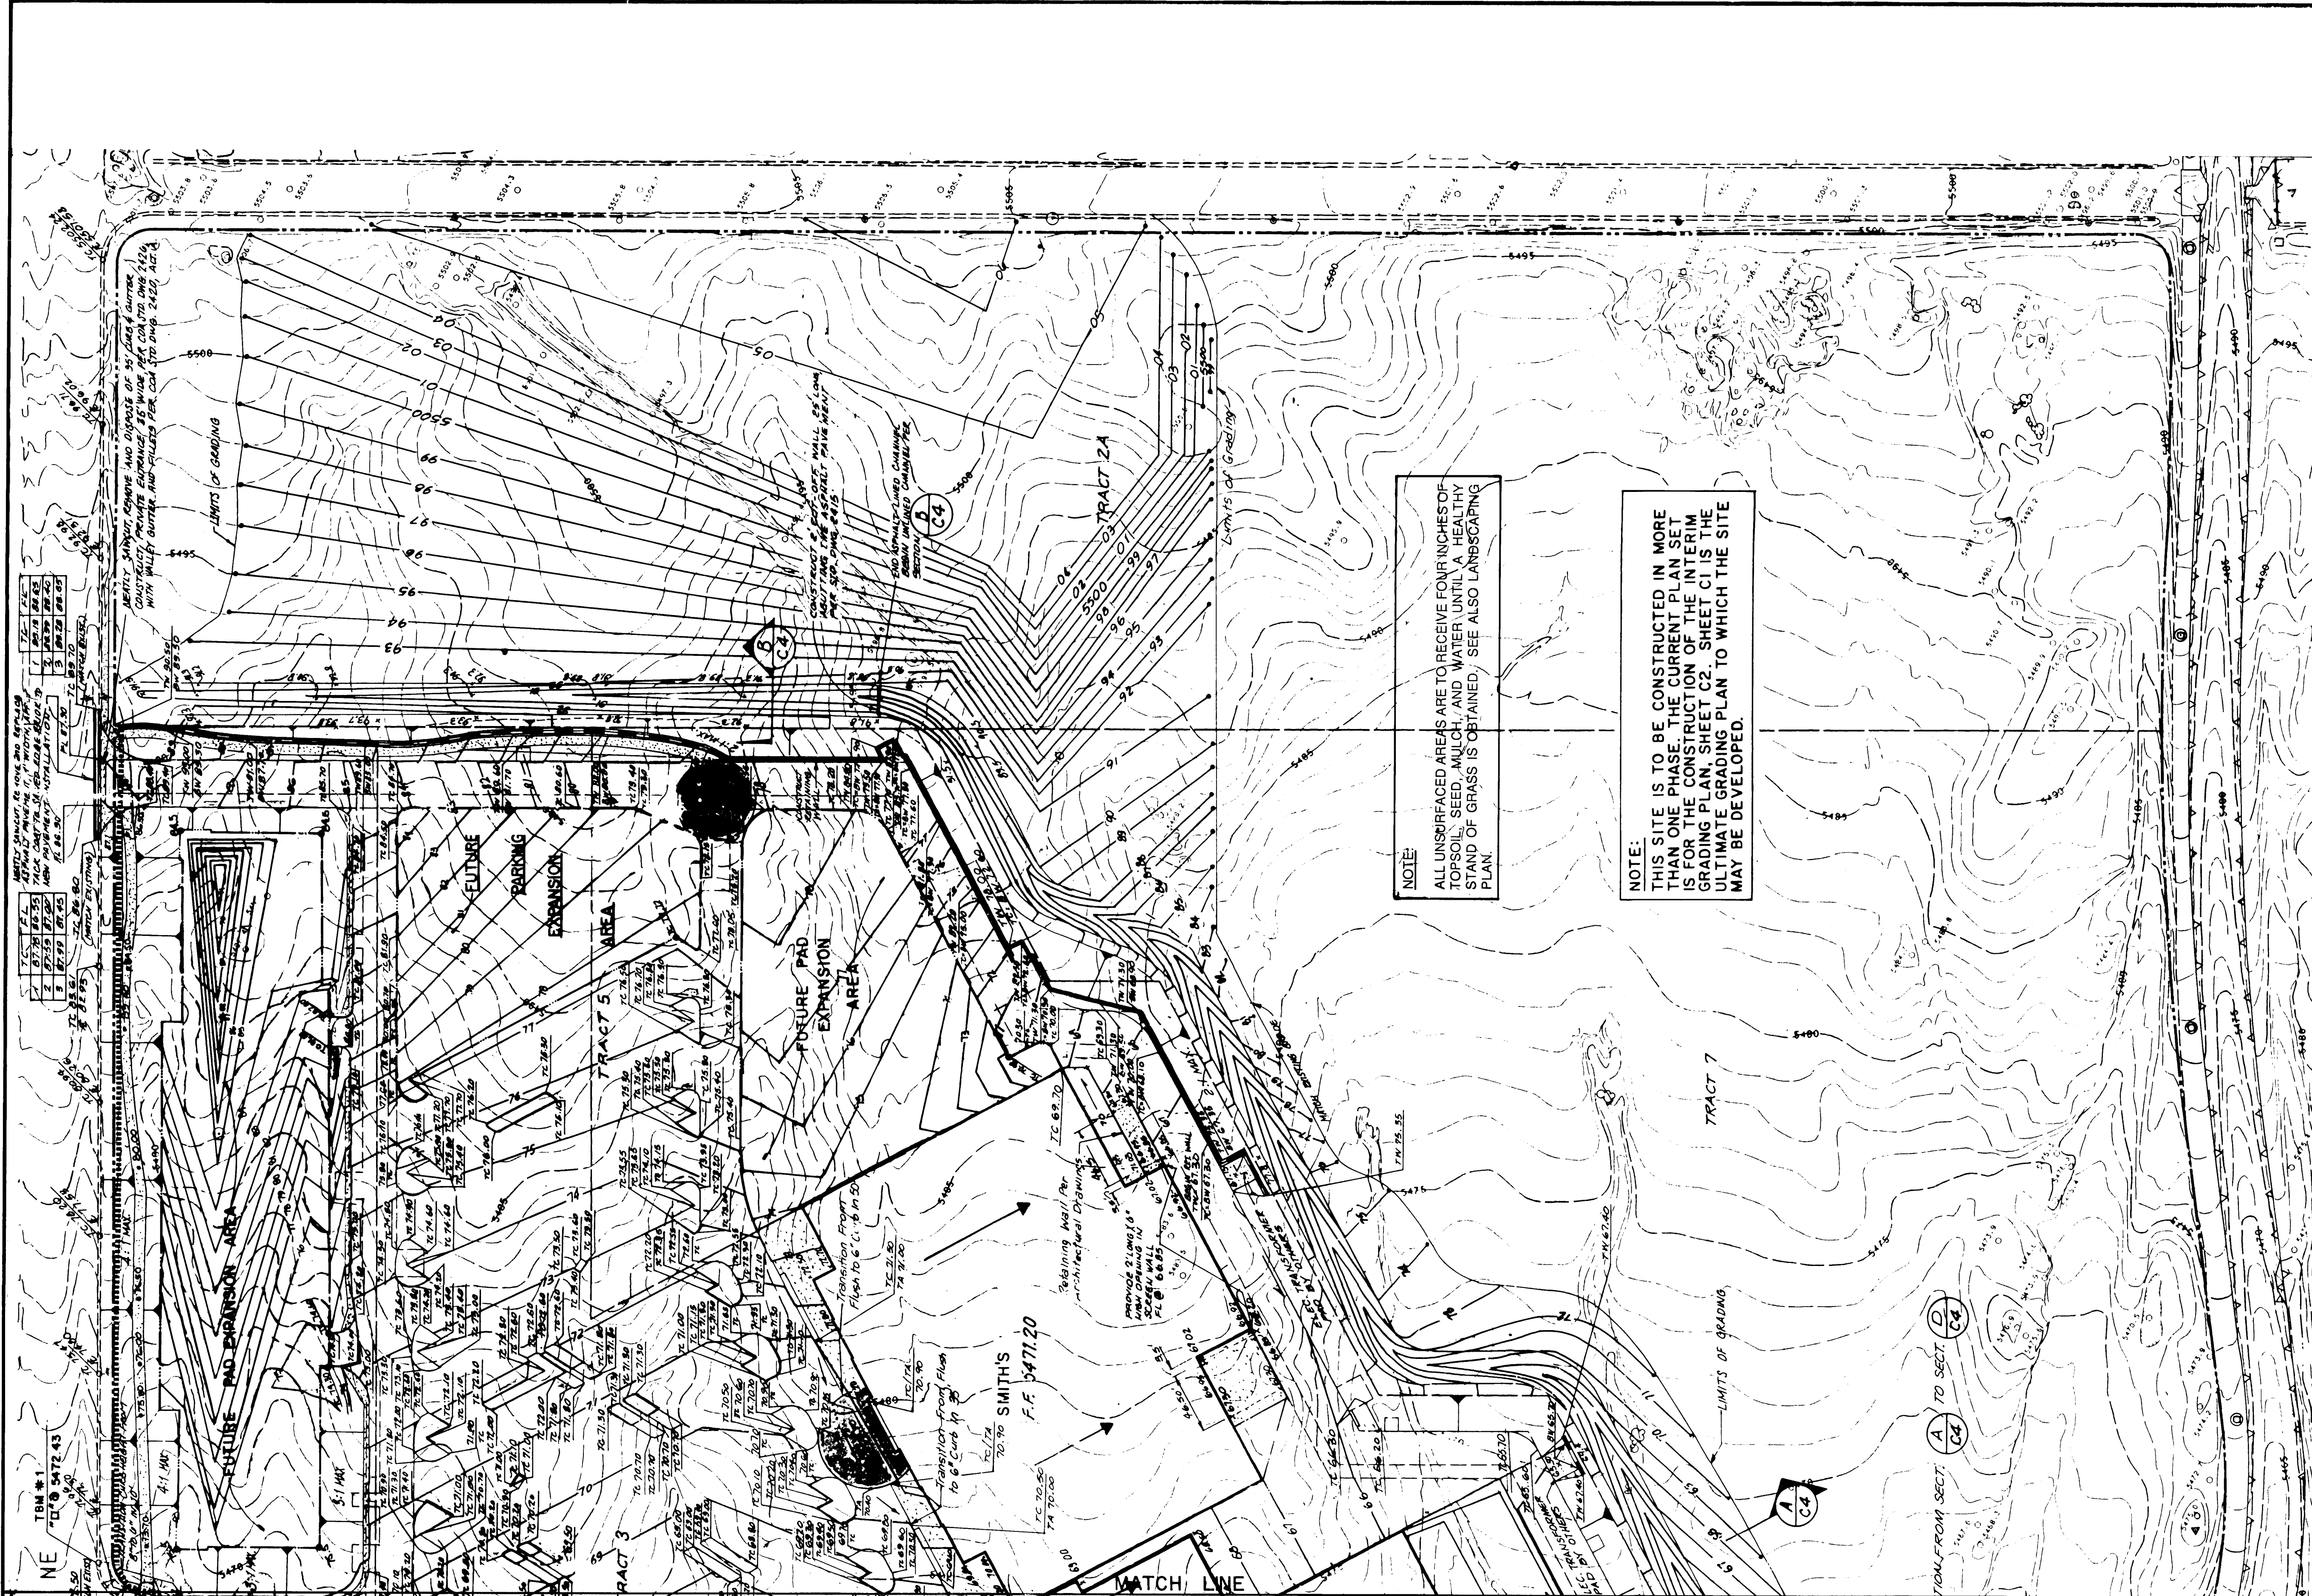

THIS GRADING PLAN IS FOR INFORMATION ONLY

- LEGEND**
- FUTURE EXPANSION
 - - - GRADE BREAK
 - 0.000.5 EXISTING SPOT ELEVATION
 - +91.8 PROPOSED SPOT ELEVATION
 - - - EXISTING CONTOUR
 - - - PROPOSED CONTOUR
 - EXISTING STORM DRAIN MANHOLE
 - PROPOSED STORM DRAIN MANHOLE
 - EXISTING STORM DRAIN INLET
 - PROPOSED STORM DRAIN INLET
 - EDGE OF ASPHALT
 - WATER BLOCK
 - RETAINING WALL
 - ROOF DRAINAGE DIRECTION
 - ACCENT PAVEMENT
 - FLOW DIRECTION
 - CONCRETE PAVEMENT
 - EROSION CONTROL BERM
 - SLOPED AREA

PROJECT BENCH MARKS
A STANDARD ACS BRASS TABLET STAMPED "12-F19 1978" SET IN TOP OF A CONCRETE POST FLUSH WITH GROUND, LOCATED 217.5' EAST OF THE CENTERLINE OF KNIGHT'S ROAD N.E. AND 6' SOUTH OF THE BACK OF CURB OF ACADEMY ROAD N.E.
ELEVATION 5412.82

- TEMPORARY BENCHMARKS**
- A "□" SCORED IN THE TOP OF CURB AT THE N.E. P.T. OF THE EAST CURB RETURN OF THE ACCESS ROAD INTO SYCAMORE PLAZA FROM ACADEMY.
ELEVATION 5472.45
 - A "□" SCORED IN THE TOP OF CURB AT THE S.W. P.T. OF THE SOUTH CURB RETURN OF THE NORTH ACCESS ROAD INTO SYCAMORE PLAZA FROM WYOMING.
ELEVATION 5455.43

APPROVED FOR ROUGH GRADING (± 1')
HYDROLOGY ENGINEER DATE


NO.	DATE	REMARKS	BY
REVISIONS			

JOB TITLE: SYCAMORE PLAZA
SHEET TITLE: INTERIM DRAINAGE AND GRADING PLAN

BOHANNAN-HUSTON, INC.
7500 JEFFERSON NE
ALBUQUERQUE, NM 87109

JOE P. KELLEY
NEW MEXICO
REGISTERED PROFESSIONAL ENGINEER
0006

 SHEET 5 OF 12



PRESSURE ZONE 4ER



WATER SHUT-OFF REQUIREMENTS:

CONTRACTOR WILL BE RESPONSIBLE FOR THE TIMING AND COORDINATION OF THE WATER SHUT-OFF REQUIREMENTS IN CONJUNCTION WITH THE COMPLETION OF THIS PROJECT.

AT LEAST THREE (3) WORKING DAYS PRIOR TO CONSTRUCTION, THE CONTRACTOR SHALL CONTACT PWD/WATER SYSTEMS DIVISION (857-8200) TO INITIATE IMPLEMENTATION OF THIS WATER SHUT-OFF PLAN.

WATER SHUT-OFF PLAN FOR
PROPOSED CONNECTION @:

- A. EXISTING ONE SYCAMORE
PLAZA; ROAD "A"
NON-PRESSURE CONNECTION
- B. INTERSECTION OF ACADEMY
ROAD & MAIN ENTRANCE.
NON-PRESSURE CONNECTION

CLOSE VALVES

341

764
(SEE DETAIL "C")



1184
(SEE DETAIL "A")

NOTE:

NO WATERLINES WILL BE CONSTRUCTED
ACROSS PRESSURE ZONE BOUNDARY.

1	2	3	4	5	6	7	8	9	10	11	12	13	14	15
2	6		4	5	5	5	.	9	0	0	6	9	3	

		CITY OF ALBUQUERQUE PUBLIC WORKS DEPARTMENT ENGINEERING GROUP			
TITLE: SYCAMORE PLAZA OVERALL PUBLIC UTILITY PLAN					
APPROVALS	ENGINEER	DATE	APPROVALS	ENGINEER	DATE
DIC CHAIRMAN	<i>W. A. Goolsby</i>	11-6-91	WATER	<i>R.W. Kame</i>	10-29-91
TRANSPORTATION	<i>W.A. Rye</i>	10-23-91	WASTE WATER	<i>R.W. Kame</i>	10-29-91
HYDROLOGY	<i>N/A R.W.</i>	10-30-91			
DRAWING NO. 4555.90		MAP NO. E&F 19820		SHEET 6 OF 12	

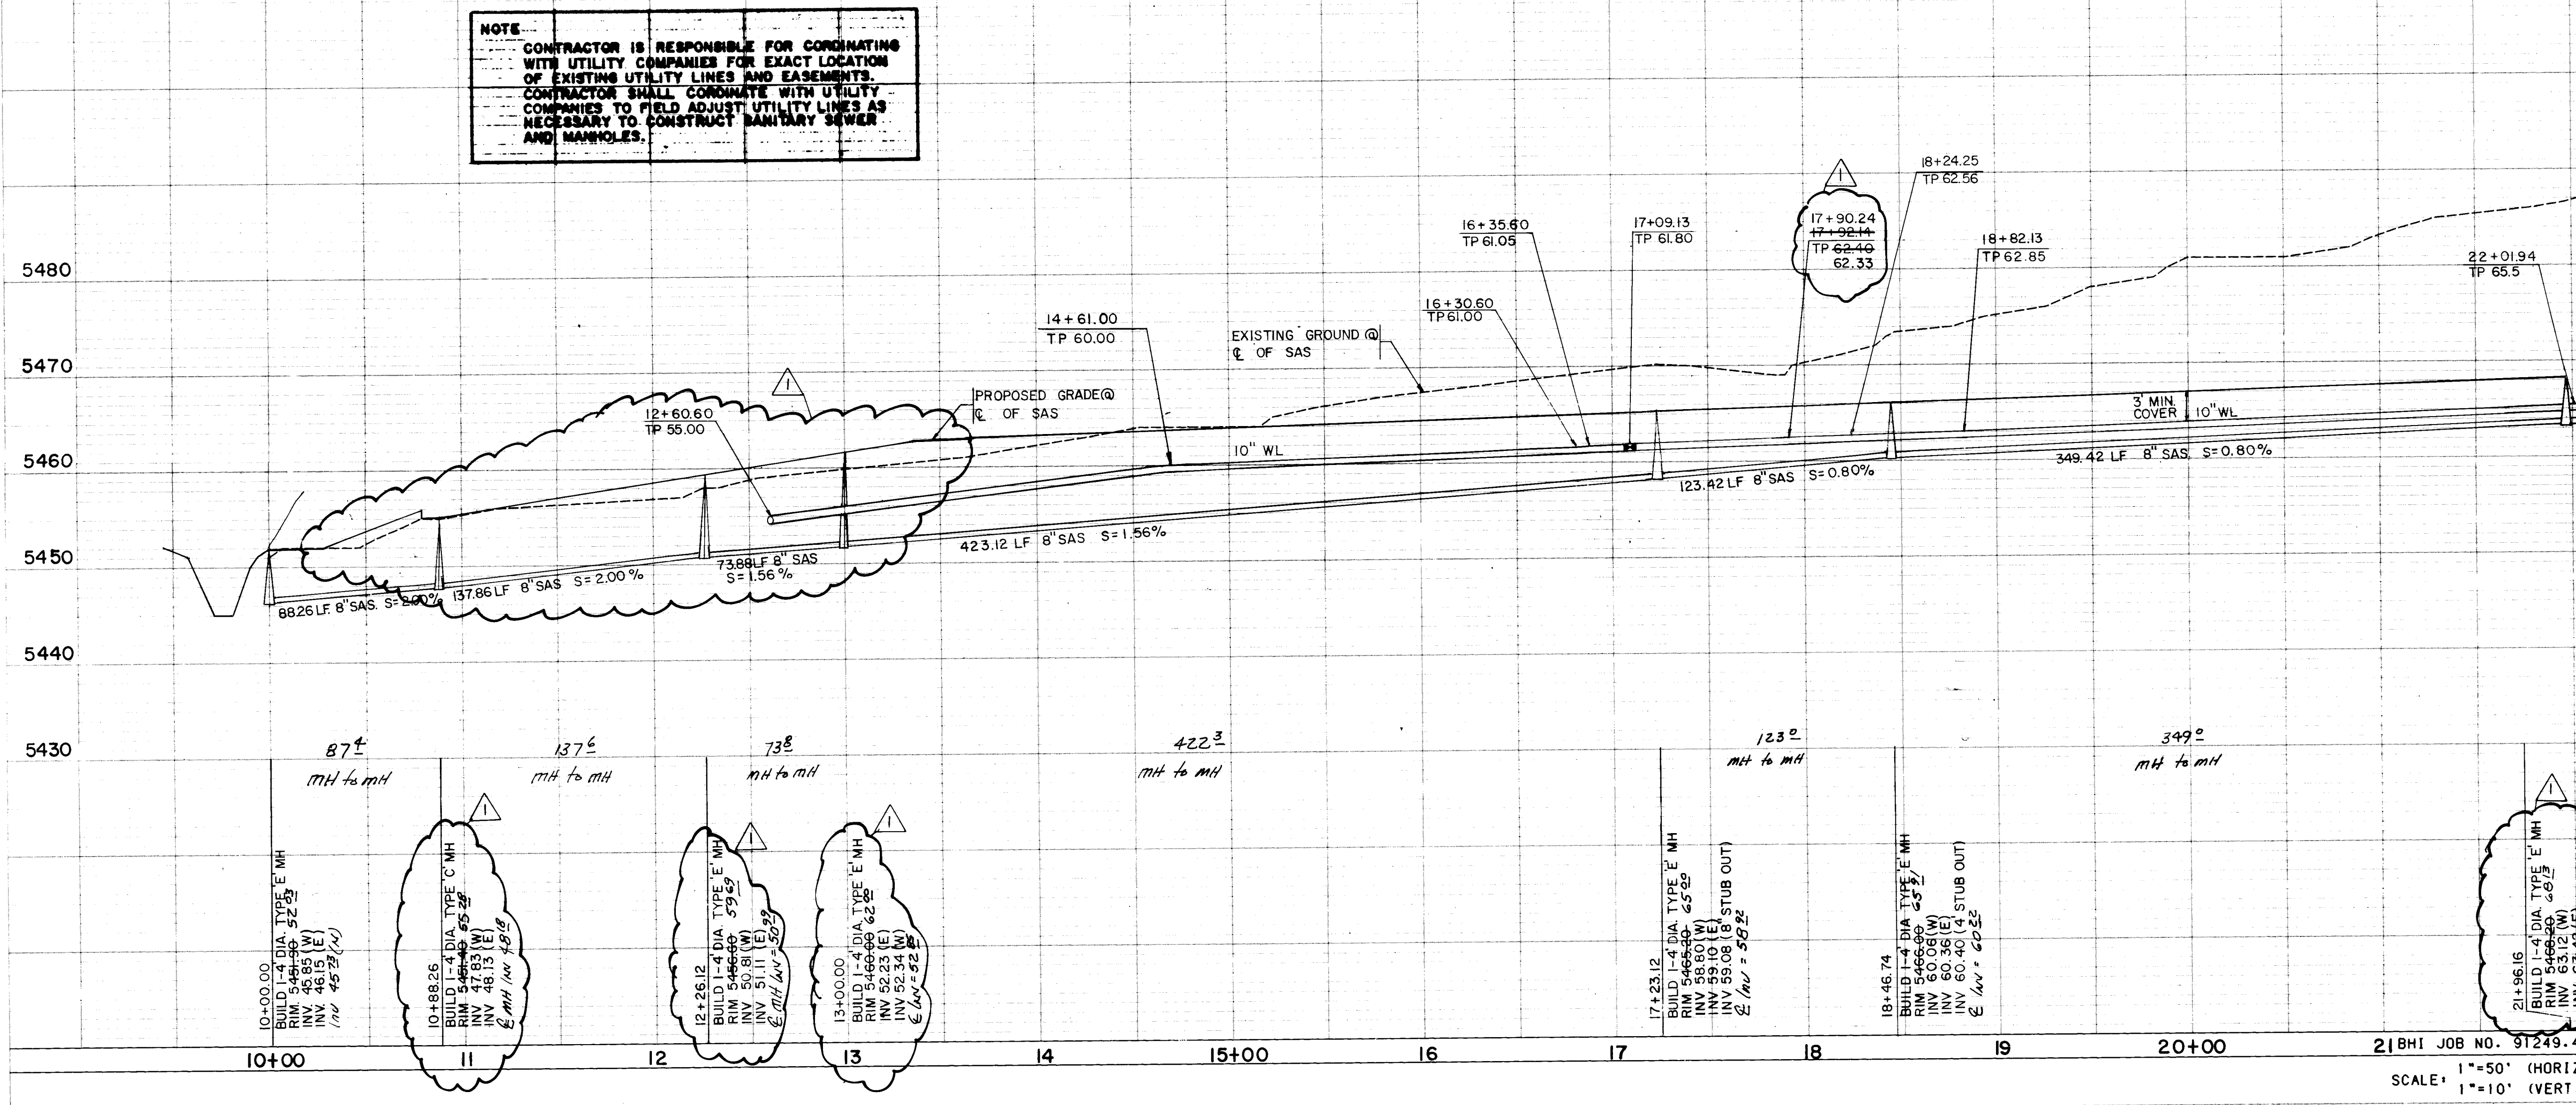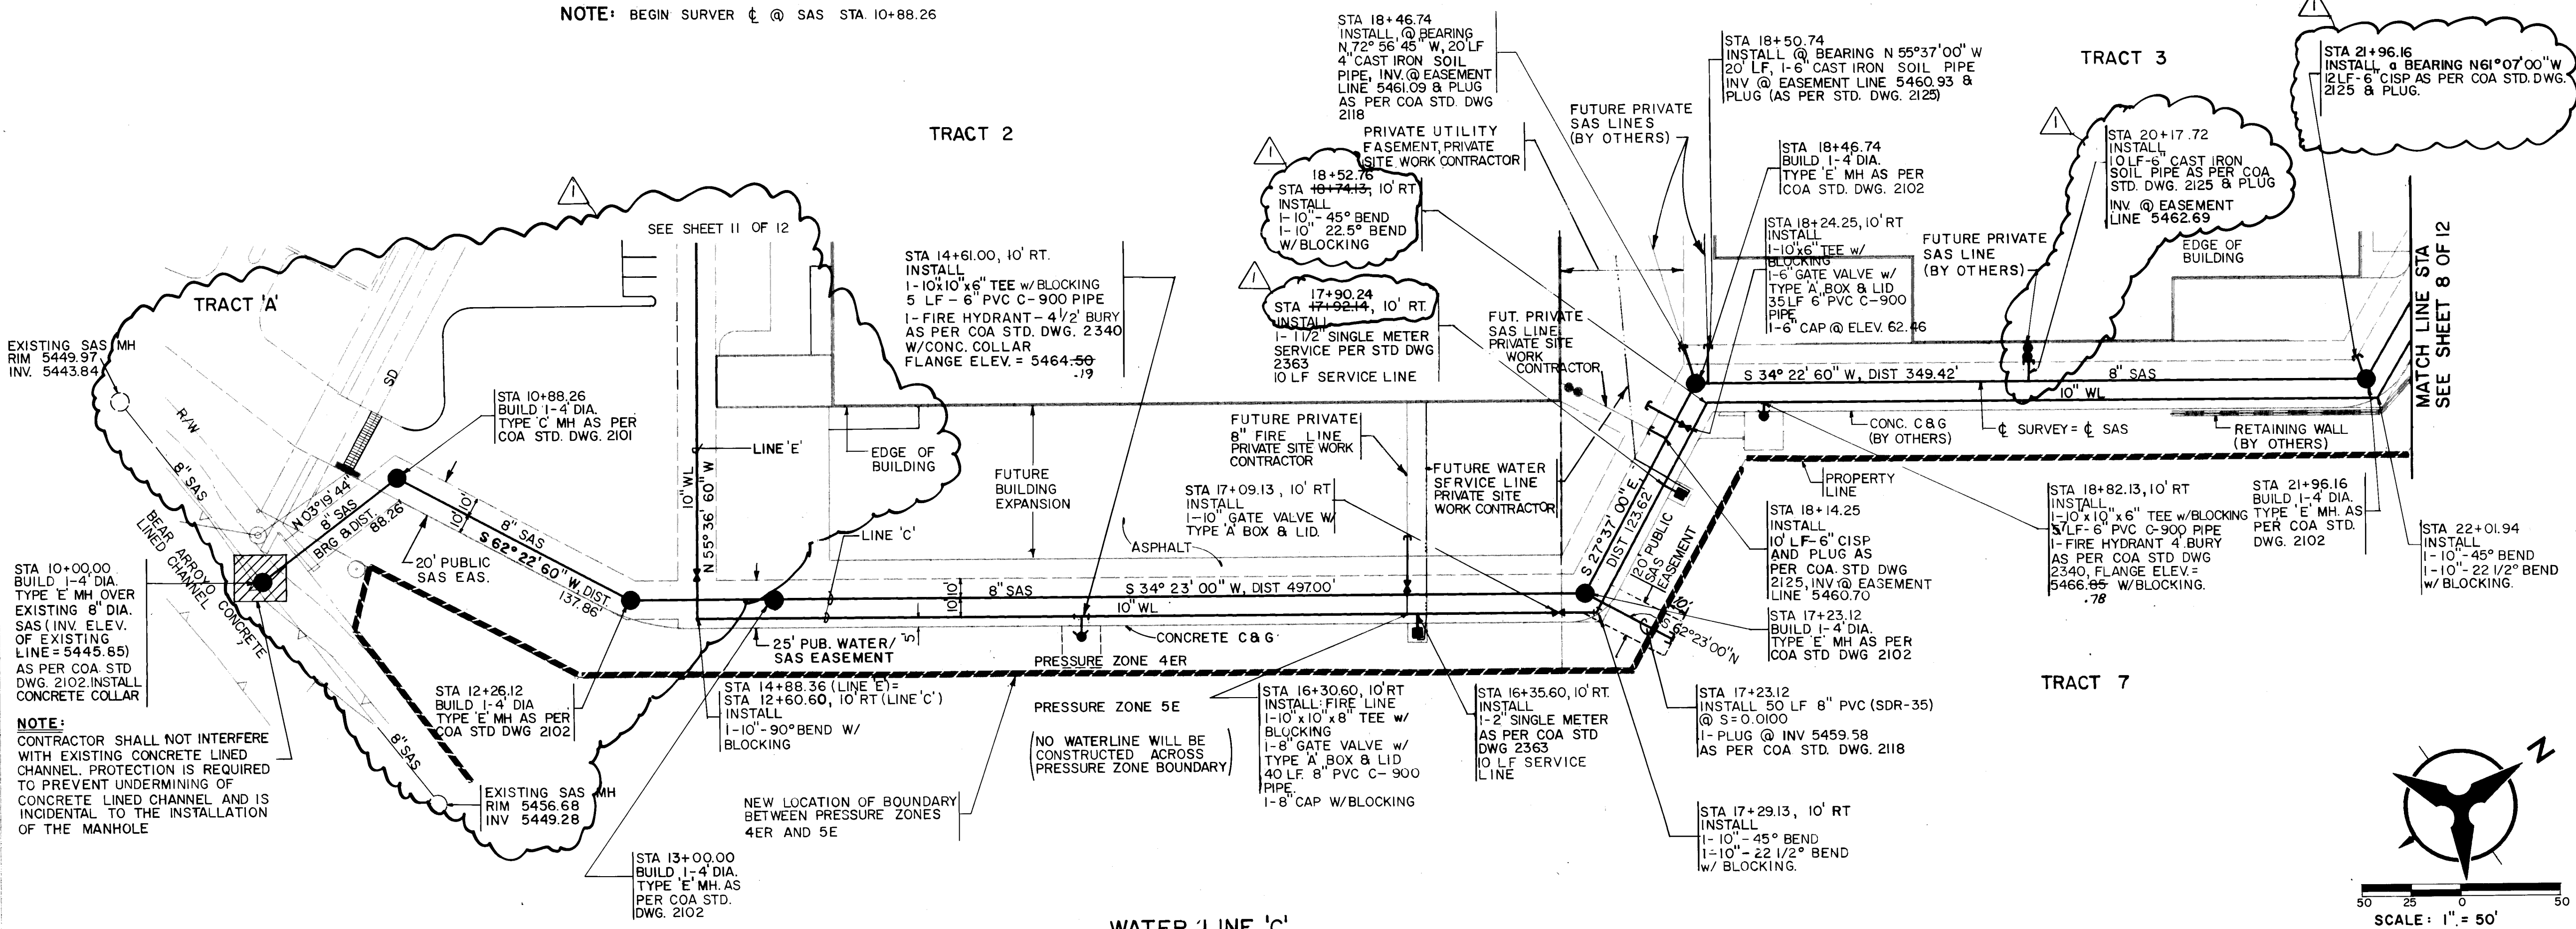

NOTES

- THE CONTRACTOR SHALL FIELD VERIFY ALL EXISTING UTILITY LOCATIONS AND NOTIFY THE ENGINEER IMMEDIATELY OF ANY DISCREPANCIES.
- CONTRACTOR IS TO INSTALL A 4" x 4" 5' POST AND END AT THE END OF EACH SANITARY SEWER SERVICE.
- CONTRACTOR IS RESPONSIBLE FOR REPAIR AND/OR REPLACEMENT OF ALL UTILITY CONDUITS AND EXISTING LINES.
- ANY ADDITIONAL GRADING REQUIRED TO MATCH PROPOSED STREET GRADES SHALL BE INCIDENTAL TO PAVING.
- CONTRACTOR SHALL PROVIDE THE INSPECTORS, (CITY AND PRIVATE) WITH THE PROPOSED HYDROSTATIC TESTING PLAN. THE PLAN MUST BE APPROVED BEFORE TESTING OPERATIONS BEGIN.
- CONTRACTOR SHALL PARK EQUIPMENT AND VEHICLES AS NOT TO INTERFERE WITH NORMAL ACTIVITIES OF RESIDENTS OR OTHER CONTRACTORS ON SITE.
- ANY DAMAGE TO THE EXISTING FACILITIES (CURB AND GUTTER, PAVEMENT, CONDUITS, LANDSCAPING, UTILITY LINES, ETC.) DURING CONSTRUCTION SHALL BE REPLACED AT THE CONTRACTOR'S EXPENSE.
- REMOVAL OF THE EXISTING CURB AND GUTTER SHALL BE AS PER COA STD. DWG 2415 (SAWCUT ONLY).

NOTE:
NO WATER LINES SHALL BE CONSTRUCTED ACROSS PRESSURE ZONE BOUNDARIES.

CONTRACTOR SHALL HAVE PROPOSED CURB STAKED PRIOR TO SETTING FINAL FIRE HYDRANT LOCATION. ANY SUBSEQUENT RELOCATION OF A FIRE HYDRANT TO CONFORM TO ACTUAL CURB LOCATIONS AND CITY OF ALBUQUERQUE STANDARD DETAILS SHALL BE MADE AT CONTRACTOR'S EXPENSE.

CONTRACTOR SHALL HAVE PROPOSED CURB STAKED PRIOR TO SETTING FINAL WATER METER SERVICE LOCATION. ANY SUBSEQUENT RELOCATION OF A WATER METER TO CONFORM TO ACTUAL CURB LOCATIONS AND CITY OF ALBUQUERQUE STANDARD DETAILS SHALL BE MADE AT CONTRACTOR'S EXPENSE.

LEGEND

AND (AL ONLY)

ENGINEER'S SEAL

REVISIONS

NO.	DATE	REMARKS
1	11-16-92	WATER
2	11-26-92	WASTE WATER

**CITY OF ALBUQUERQUE
PUBLIC WORKS DEPARTMENT
ENGINEERING GROUP**

**TITLE: SYCAMORE PLAZA
WATER & SANITARY PLAN & PROFILE
LINE 'C'**


APPROVALS

ENGINEER	DATE	APPROVALS	ENGINEER	DATE
FOR CHAIRMAN	11-16-92	WATER	R.W. Kame	10-28-92
TRANSPORTATION	11-26-92	WASTE WATER	R.W. Kame	10-28-92
HYDROLOGY	11-26-92			


DRAWING NO. 4555.90

MAP NO. E&F 19820

SHEET 7 OF 12

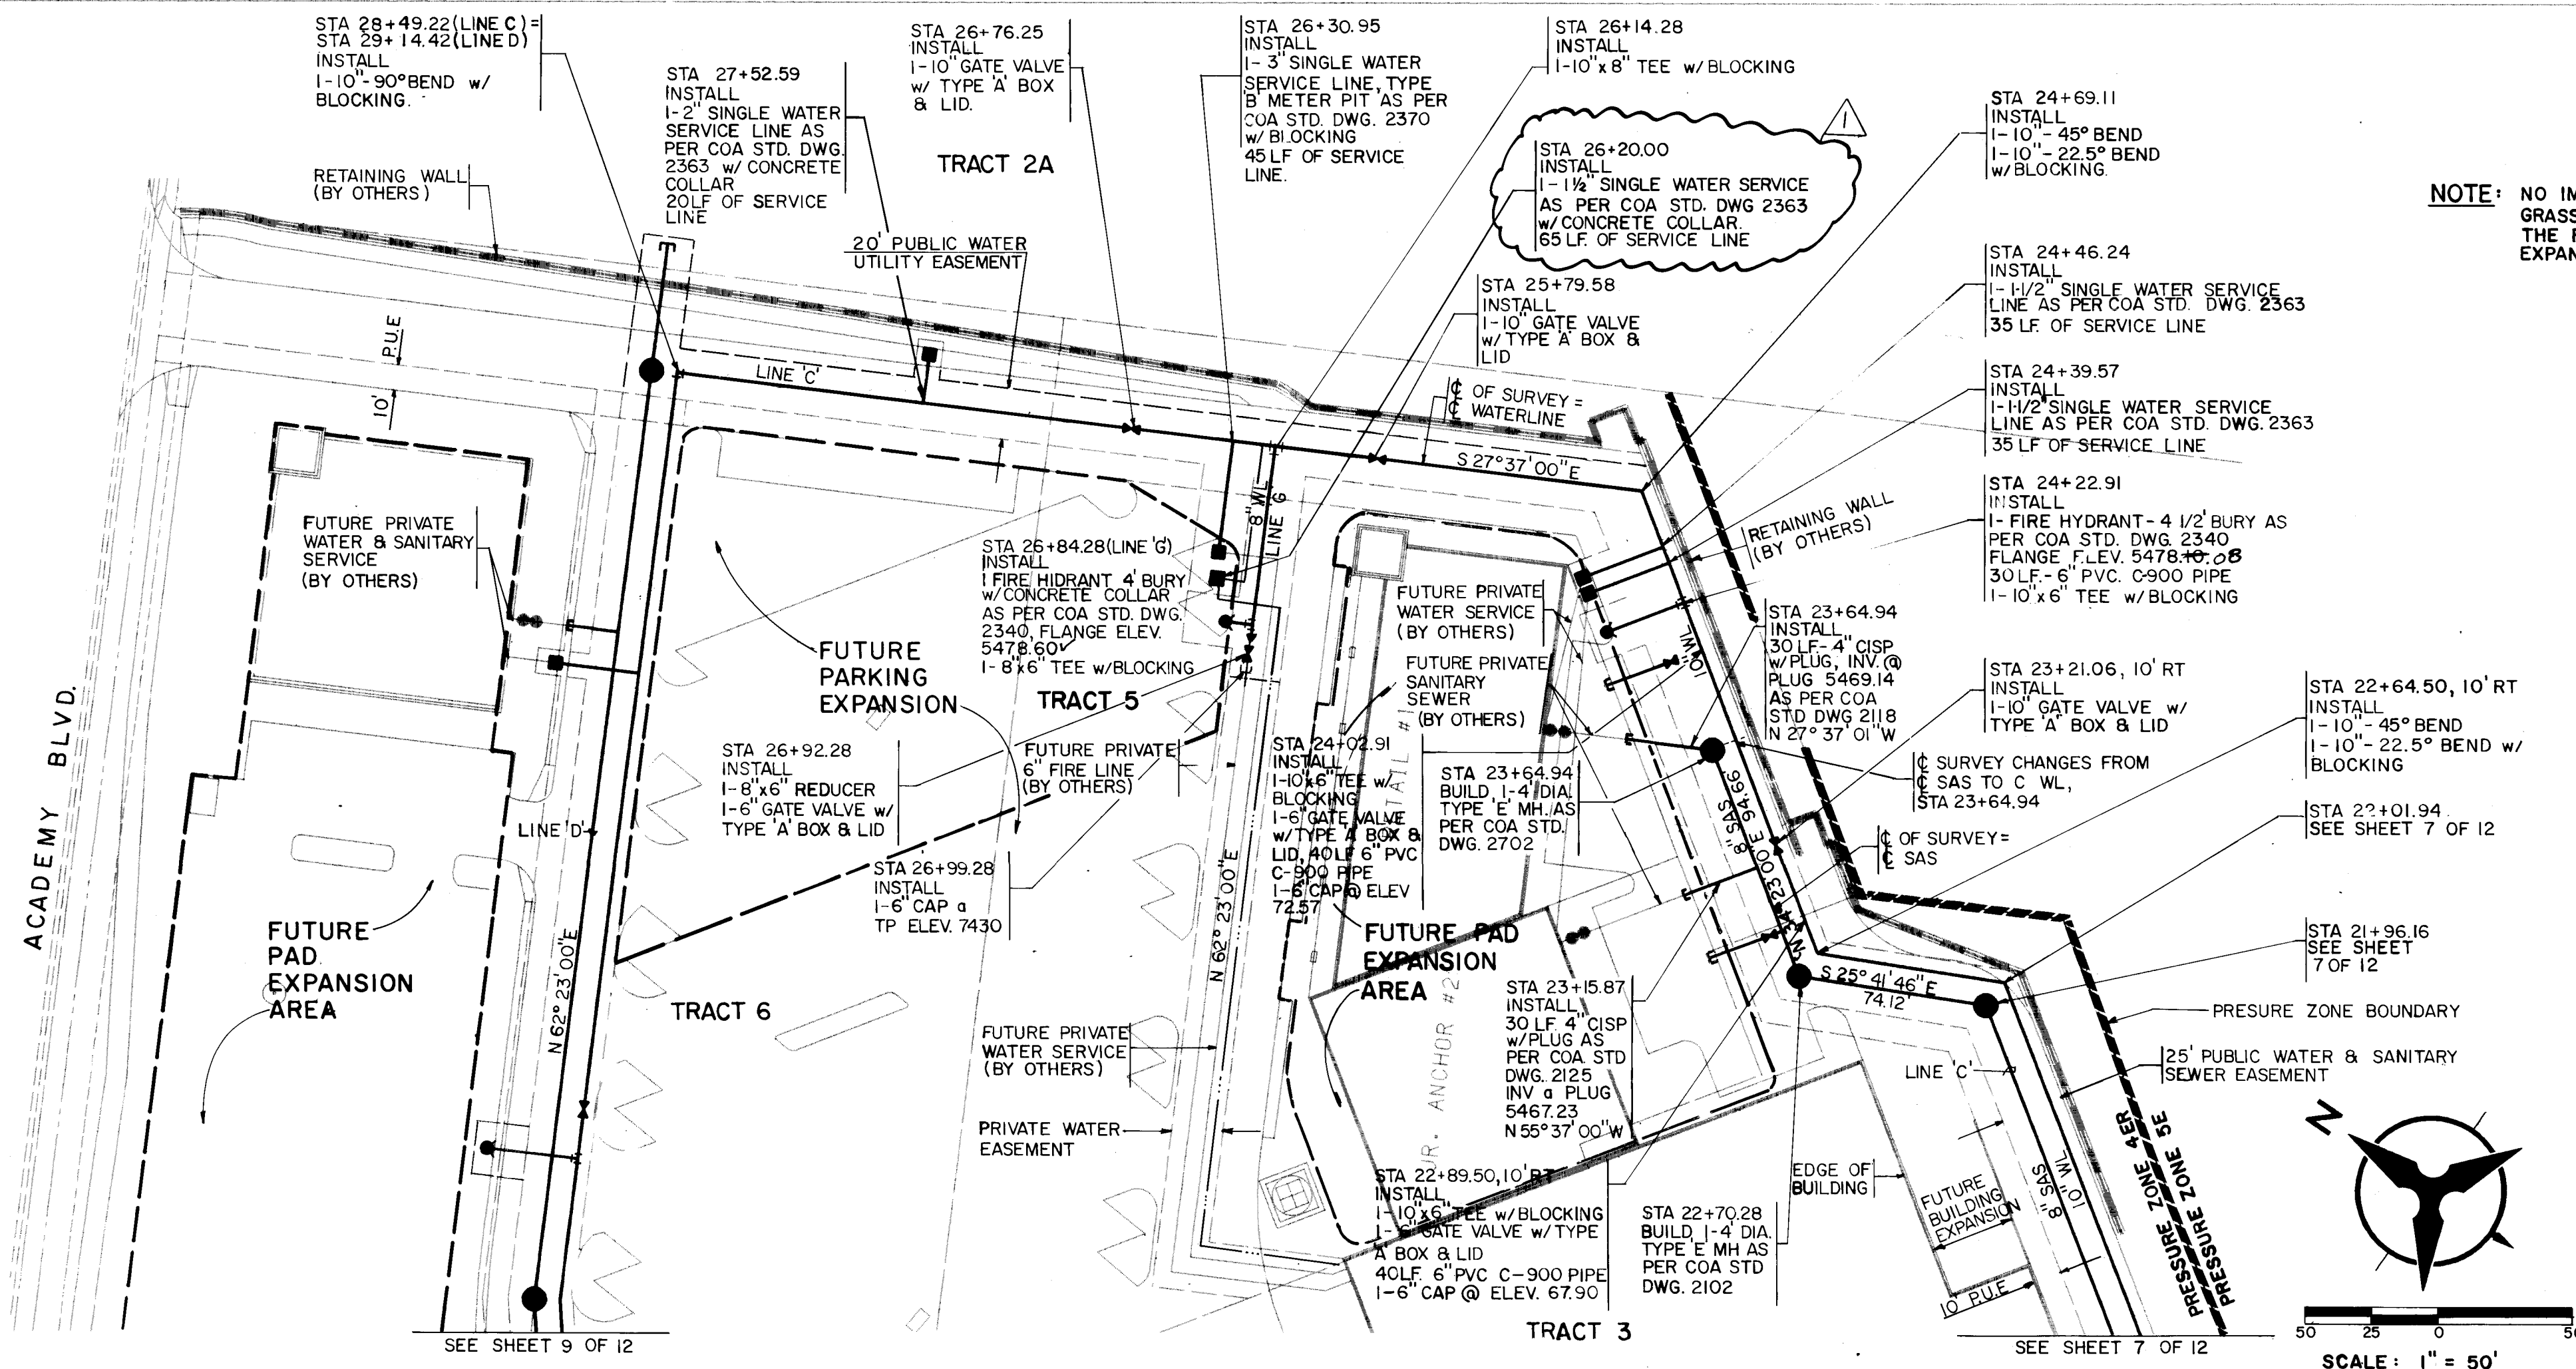

WATER LINE 'C' (CONTINUED)

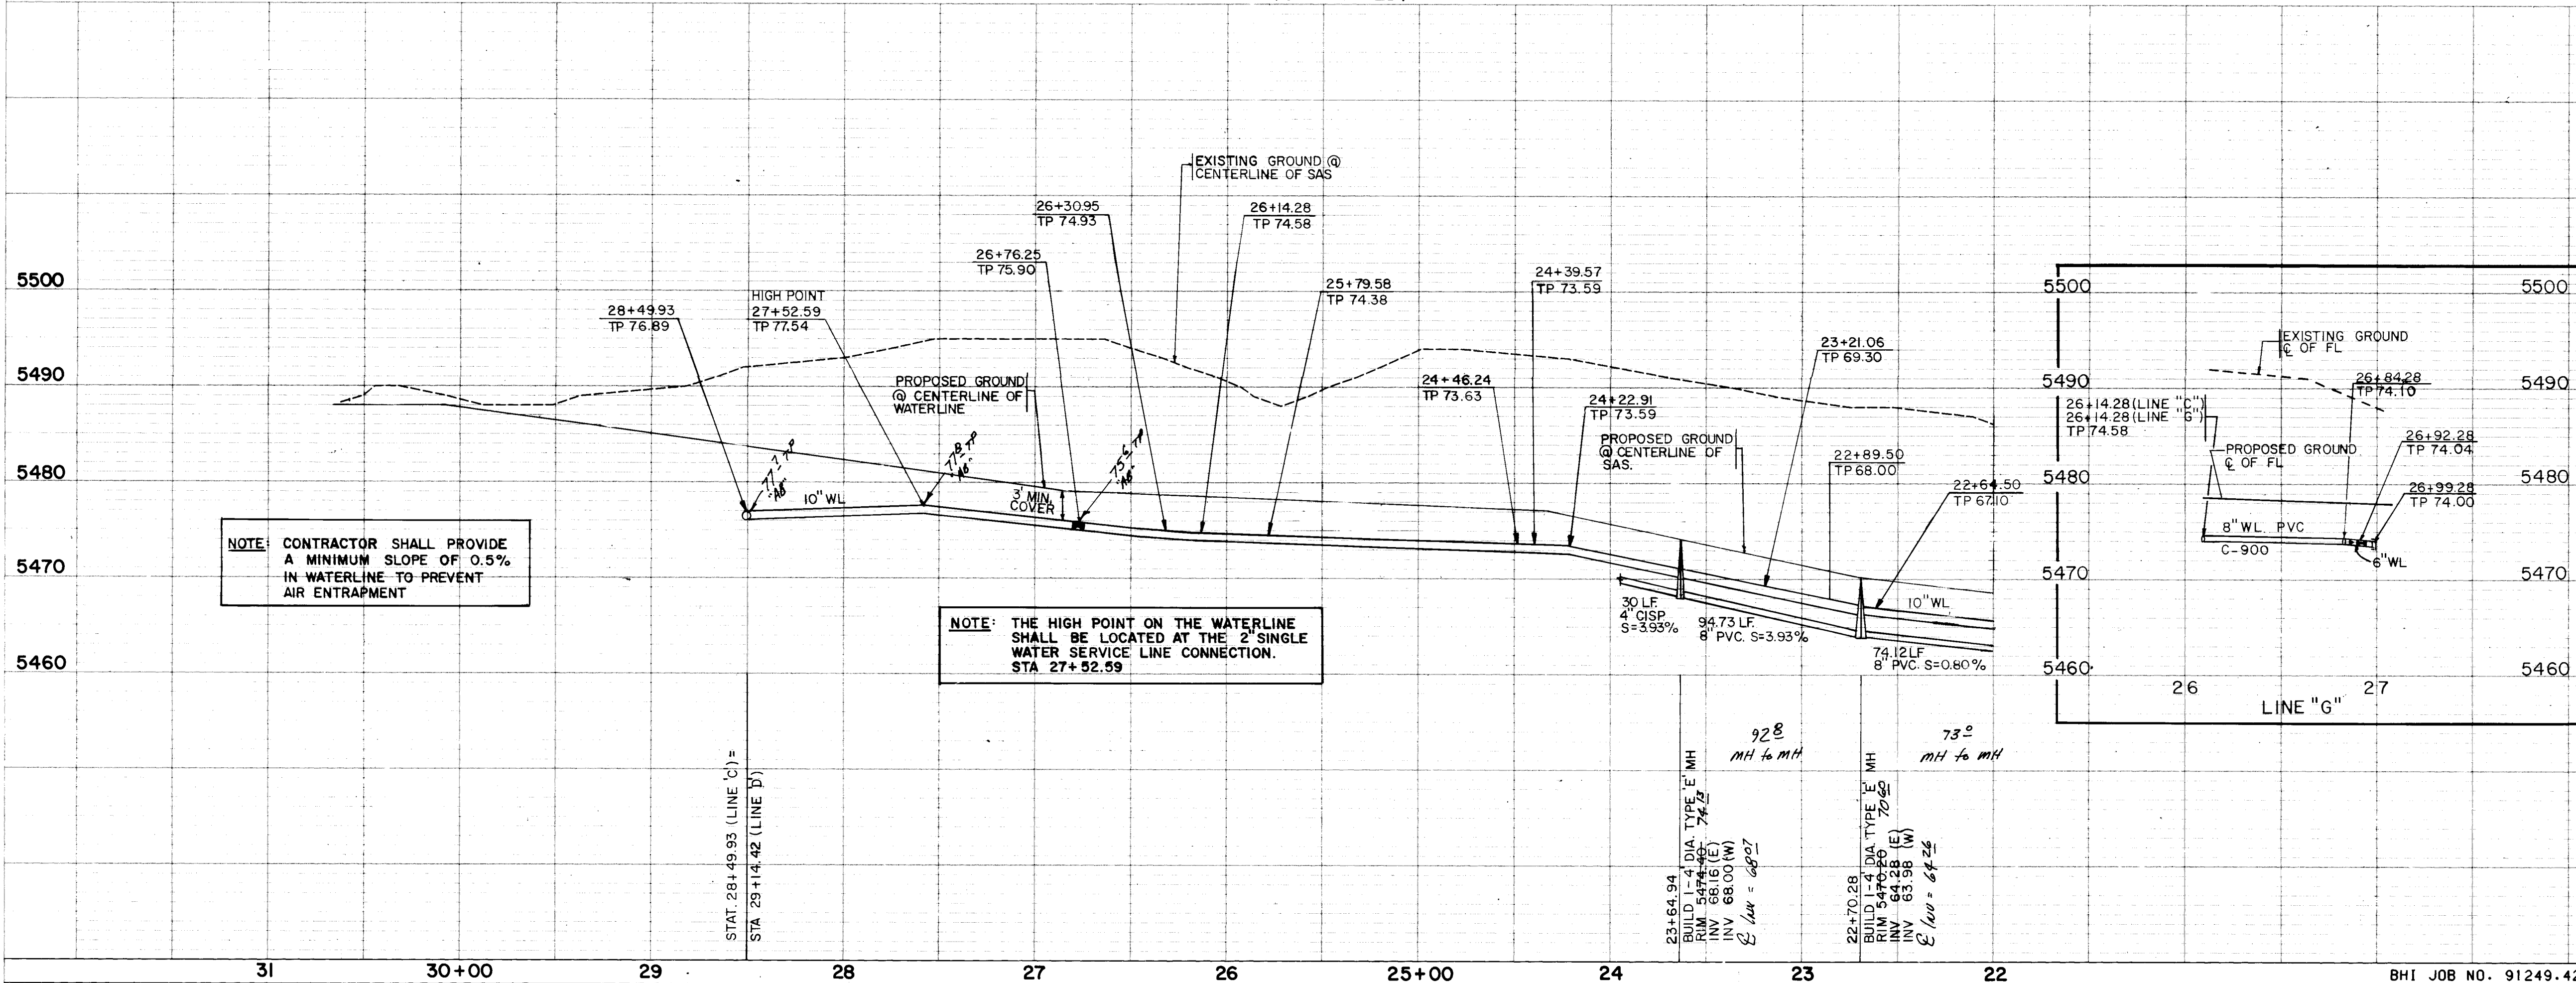


- NOTES**
1. THE CONTRACTOR SHALL FIELD VERIFY ALL EXISTING UTILITY LOCATIONS AND NOTIFY THE ENGINEER IMMEDIATELY OF ANY DISCREPANCIES.
 2. CONTRACTOR IS TO INSTALL A 4" x 4" x 5' POST AND END AT THE END OF EACH SANITARY SEWER SERVICE.
 3. CONTRACTOR IS RESPONSIBLE FOR REPAIR AND/OR REPLACEMENT OF ALL UTILITY CONDUITS AND EXISTING LINES.
 4. ANY ADDITIONAL GRADING REQUIRED TO MATCH PROPOSED STREET GRADES SHALL BE INCIDENTAL TO PAVING.
 5. CONTRACTOR SHALL PROVIDE THE INSPECTORS, (CITY AND PRIVATE) WITH THE PROPOSED HYDROSTATIC TESTING PLAN. THE PLAN MUST BE APPROVED BEFORE TESTING OPERATIONS BEGIN.
 6. CONTRACTOR SHALL PARK EQUIPMENT AND VEHICLES AS NOT TO INTERFERE WITH NORMAL ACTIVITIES OF RESIDENTS OR OTHER CONTRACTORS ON SITE.
 7. ANY DAMAGE TO THE EXISTING FACILITIES (CURB AND GUTTER, PAVEMENT, CONDUITS, LANDSCAPING, UTILITY LINES, ETC.) DURING CONSTRUCTION SHALL BE REPLACED AT THE CONTRACTORS EXPENSE.
 8. REMOVAL OF THE EXISTING CURB AND GUTTER SHALL BE AS PER COA STD. DWG 2415 (SAWCUT ONLY).
- NOTE:**
- NO WATER LINES SHALL BE CONSTRUCTED ACROSS PRESSURE ZONE BOUNDARIES.

CONTRACTOR SHALL HAVE PROPOSED CURB STAKED PRIOR TO SETTING FINAL FIRE HYDRANT LOCATION. ANY SUBSEQUENT RELOCATION OF A FIRE HYDRANT TO CONFORM TO ACTUAL CURB LOCATIONS AND CITY OF ALBUQUERQUE STANDARD DETAILS SHALL BE MADE AT CONTRACTOR'S EXPENSE.

CONTRACTOR SHALL HAVE PROPOSED CURB STAKED PRIOR TO SETTING FINAL WATER METER SERVICE LOCATION. ANY SUBSEQUENT RELOCATION OF A WATER METER TO CONFORM TO ACTUAL CURB LOCATIONS AND CITY OF ALBUQUERQUE STANDARD DETAILS SHALL BE MADE AT CONTRACTOR'S EXPENSE.

ENGINEER'S SEAL		SURVEY INFORMATION		BENCH MARKS		AS BUILT INFORMATION	
LEGEND		FIELD NOTES		TEMPORARY BENCH MARKS		WORK STAKED BY	
===== WATER ZONE BOUNDARY		NO. BY DATE		1. A * SCORED IN THE TOP OF CURB AT THE NE PT. OF THE EAST CURB RETURN OF THE ACCESS ROAD INTO SYCAMORE PLAZA FROM ACADEMY. ELEVATION = 5472.45		CONTRACTOR 7/12/93	
				2. A * SCORED IN THE TOP OF CURB AT THE SW PT. OF THE SOUTH CURB RETURN OF THE NORTH ACCESS ROAD INTO SYCAMORE PLAZA FROM WYOMING. ELEVATION = 5455.43		STAKED BY: WALKER SURVEY 5/93	
						ACCEPTANCE BY: R.E.C. DATE 8/93	
						FIELD LOCATION BY: Walker Survey 7/93	
						DRAWINGS CORRECTED BY: J.H.L./K.P. DATE 7/93	
						MICRO-FILM INFORMATION	
						RECORDED BY DATE	
						NO.	

CITY OF ALBUQUERQUE PUBLIC WORKS DEPARTMENT ENGINEERING GROUP		
TITLE: SYCAMORE PLAZA WATER & SANITARY SEWER PLAN & PROFILE LINE C		
APPROVALS	ENGINEER	DATE
DRG CHAIRMAN	R.W. Kame	11-6-92
TRANSPORTATION	N/A RHD	10-28-92
HYDROLOGY	N/A JG	10-30-92
DESIGNED BY	KGP	DATE
DRAWN BY	JAG	DATE
CHECKED BY	JRT	DATE
BHI JOB NO. 91249.42		
DRAWING NO. 4555.90	MAP NO. E&F 19820	SHEET 8 OF 12

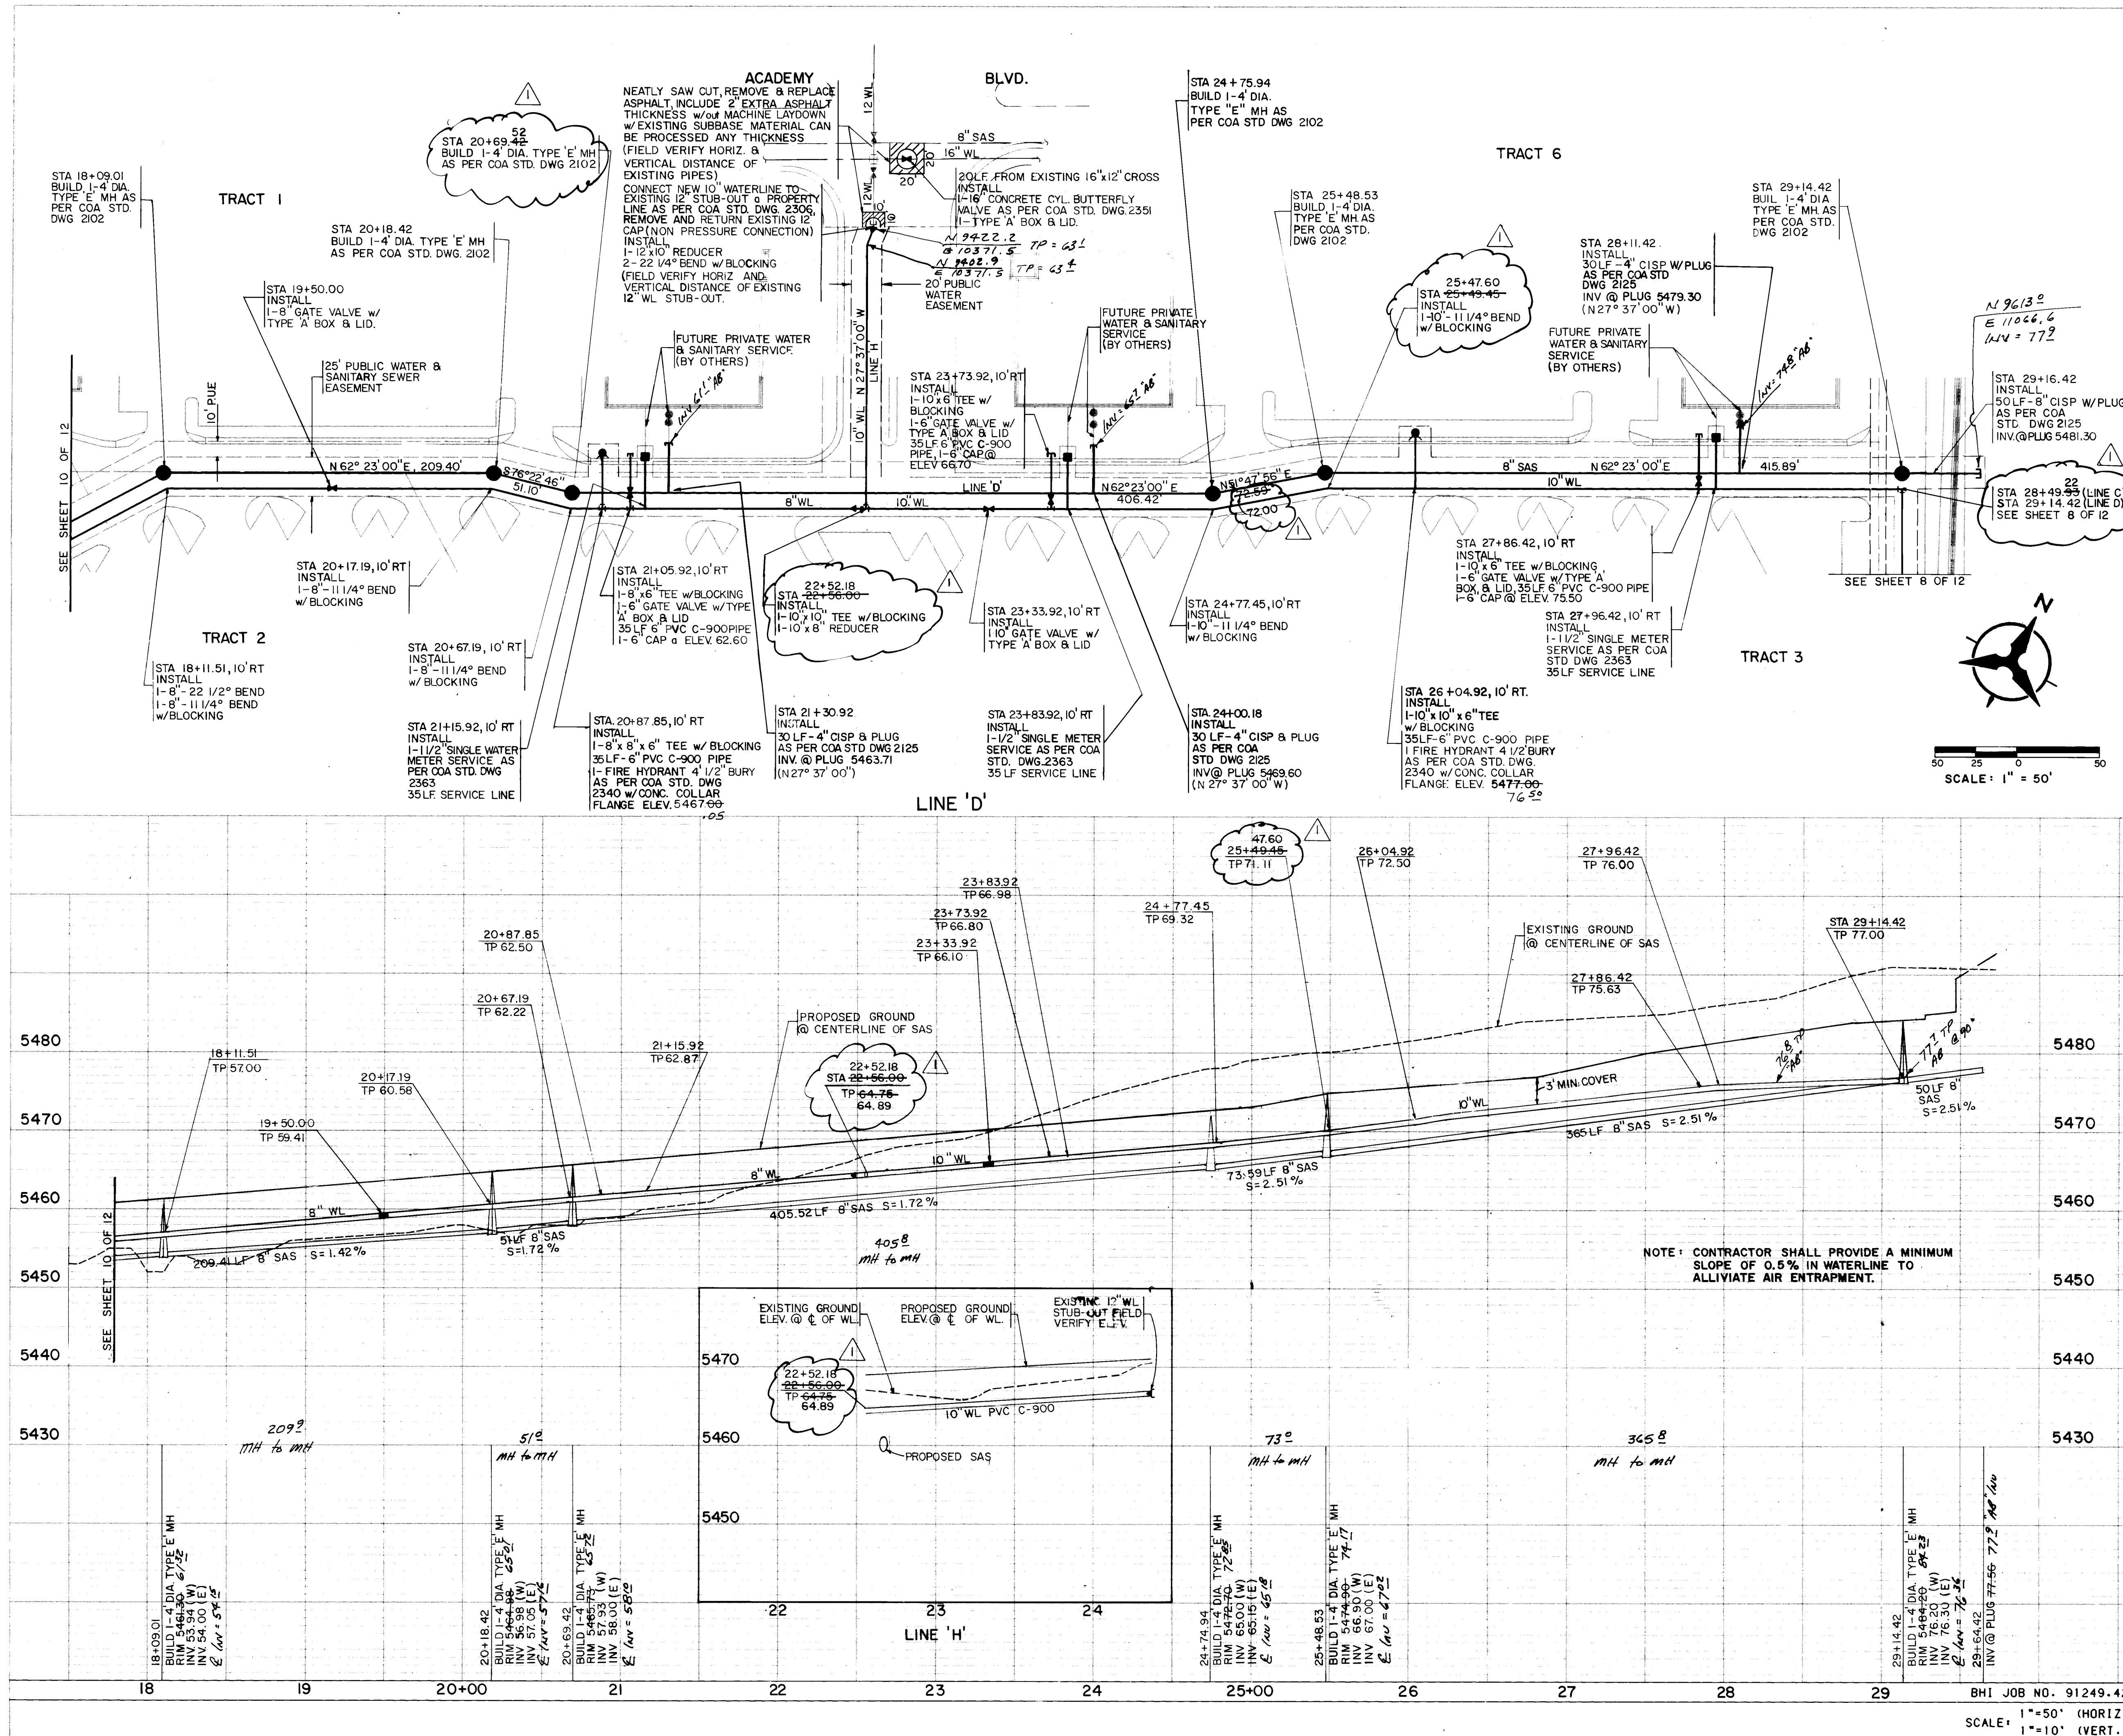

NOTES

- THE CONTRACTOR SHALL FIELD VERIFY ALL EXISTING UTILITY LOCATIONS AND NOTIFY THE ENGINEER IMMEDIATELY OF ANY DISCREPANCIES.
- CONTRACTOR IS TO INSTALL A 4" x 4" x 5' POST AND END AT THE END OF EACH SANITARY SEWER SERVICE.
- CONTRACTOR IS RESPONSIBLE FOR REPAIR AND/OR REPLACEMENT OF ALL UTILITY CONDUITS AND EXISTING LINES.
- ANY ADDITIONAL GRADING REQUIRED TO MATCH PROPOSED STREET GRADES SHALL BE INCIDENTAL TO PAVING.
- CONTRACTOR SHALL PROVIDE THE INSPECTORS, (CITY AND PRIVATE) WITH THE PROPOSED HYDROSTATIC TESTING PLAN. THE PLAN MUST BE APPROVED BEFORE TESTING OPERATIONS BEGIN.
- CONTRACTOR SHALL PARK EQUIPMENT AND VEHICLES AS NOT TO INTERFERE WITH NORMAL ACTIVITIES OF RESIDENTS OR OTHER CONTRACTORS ON SITE.
- ANY DAMAGE TO THE EXISTING FACILITIES (CURB AND GUTTER, PAVEMENT, CONDUITS, LANDSCAPING, UTILITY LINES, ETC.) DURING CONSTRUCTION SHALL BE REPLACED AT THE CONTRACTOR'S EXPENSE.
- REMOVAL OF THE EXISTING CURB AND GUTTER SHALL BE AS PER COA STD. DWG 2415 (SAWCUT ONLY).

NOTE:
NO WATER LINES SHALL BE CONSTRUCTED ACROSS PRESSURE ZONE BOUNDARIES.

CONTRACTOR SHALL HAVE PROPOSED CURB STAKED PRIOR TO SETTING FINAL FIRE HYDRANT LOCATION. ANY SUBSEQUENT RELOCATION OF A FIRE HYDRANT TO CONFORM TO ACTUAL CURB LOCATIONS AND CITY OF ALBUQUERQUE STANDARD DETAILS SHALL BE MADE AT CONTRACTOR'S EXPENSE.

CONTRACTOR SHALL HAVE PROPOSED CURB STAKED PRIOR TO SETTING FINAL WATER METER SERVICE LOCATION. ANY SUBSEQUENT RELOCATION OF A WATER METER TO CONFORM TO ACTUAL CURB LOCATIONS AND CITY OF ALBUQUERQUE STANDARD DETAILS SHALL BE MADE AT CONTRACTOR'S EXPENSE.

ENGINEER'S SEAL

STAMP: *[Signature]*
DATE: 6-23-93

AS BUILT INFORMATION	
CONTRACTOR	DATE
TRIPLE H	5/93

BENCH MARKS	
TEMPORARY BENCH MARKS	DATE
1. A * * SCORED IN THE TOP OF CURB AT THE NE PT OF THE EAST CURB RETURN OF THE ACCESS ROAD INTO SYCAMORE PLAZA FROM ACADEMY. ELEVATION = 5472.45	5/93
2. A * * SCORED IN THE TOP OF CURB AT THE SW PT OF THE SOUTH CURB RETURN OF THE NORTH ACCESS ROAD INTO SYCAMORE PLAZA FROM WYOMING. ELEVATION = 5455.43	5/93

SURVEY INFORMATION	
FIELD NOTES	DATE
NO.	BY

REVISIONS	
NO.	DATE
1	1/93

DESIGNED BY KGP	
DATE	DATE
JAC	JRT

CITY OF ALBUQUERQUE
PUBLIC WORKS DEPARTMENT
ENGINEERING GROUP

TITLE: SYCAMORE PLAZA
WATER & SANITARY SEWER PLAN & PROFILE
LINE 'D'

APPROVALS	ENGINEER	DATE	APPROVALS	ENGINEER	DATE
DRC CHAIRMAN	<i>[Signature]</i>	11-6-92	WATER	<i>[Signature]</i>	10-28-92
TRANSPORTATION	<i>[Signature]</i>	10-23-92	WASTE WATER	<i>[Signature]</i>	10-28-92
HYDROLOGY	<i>[Signature]</i>	10-30-92			




BHI JOB NO. 91249.42

SCALE: 1"=50' (HORIZ.)
1"=10' (VERT.)

DRAWING NO. **4555.90**

MAP NO. E&F 19820

SHEET **9** OF **12**

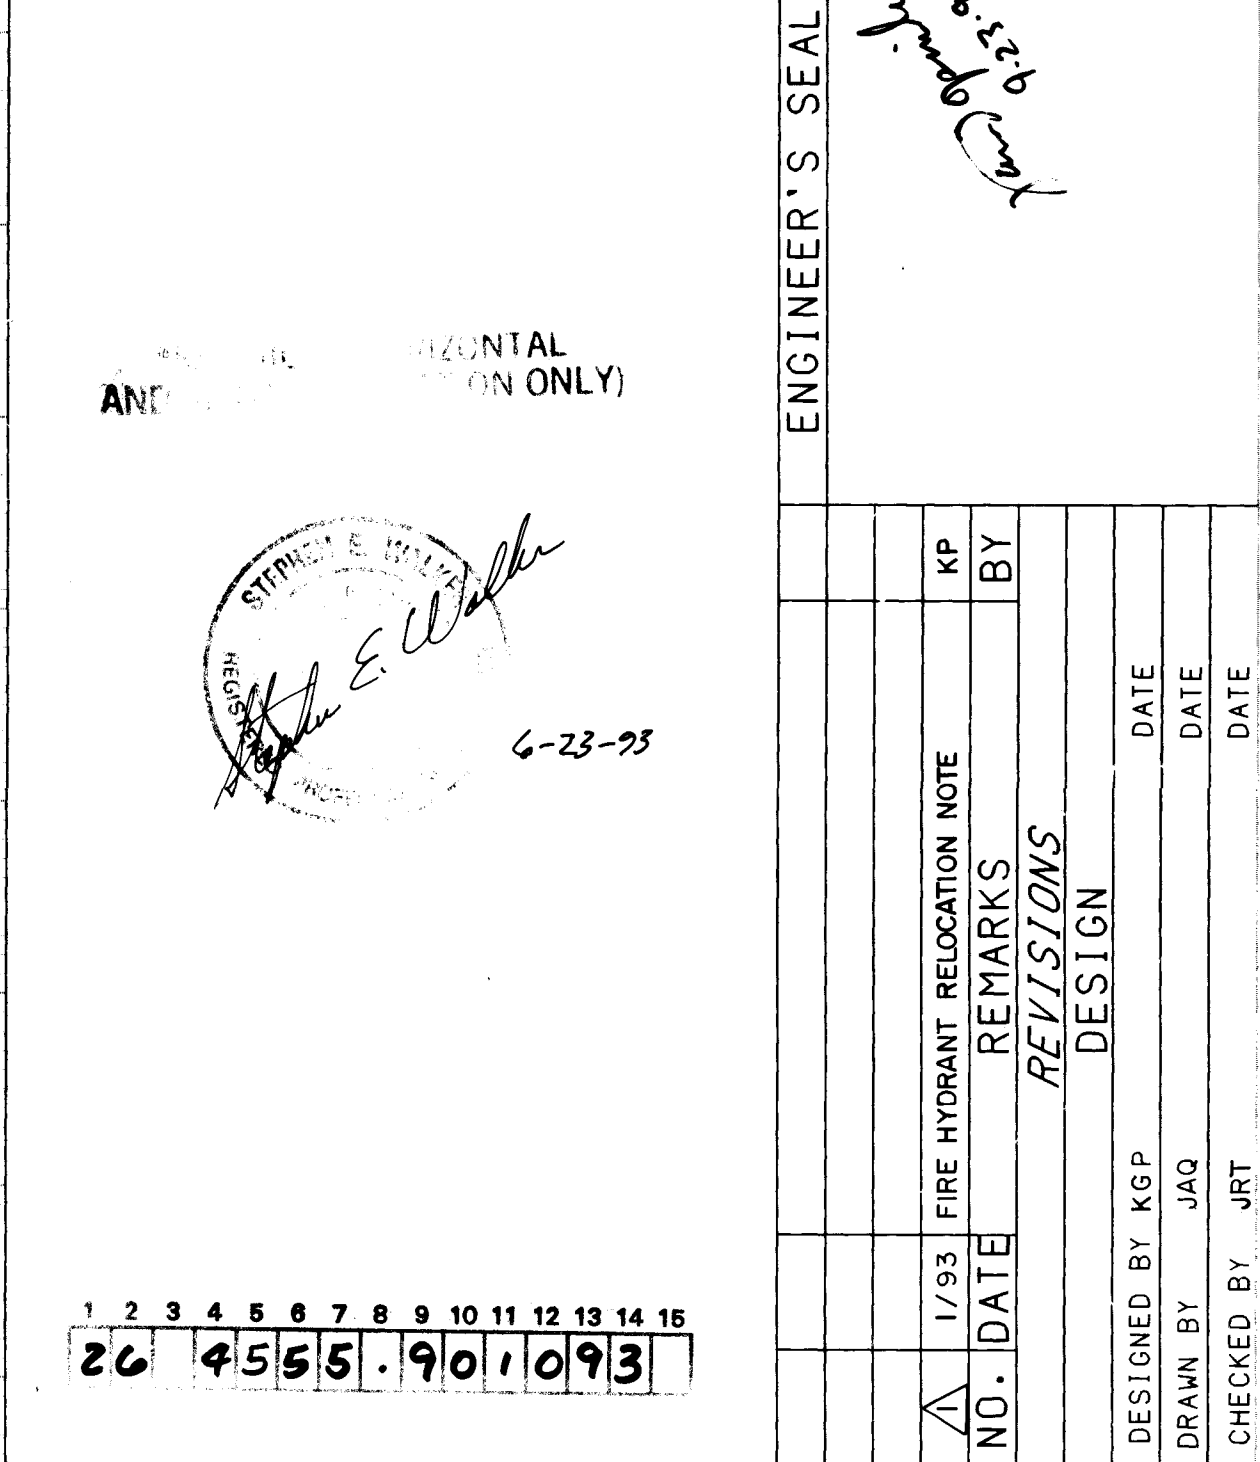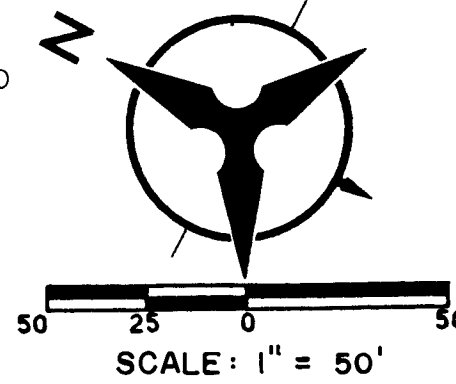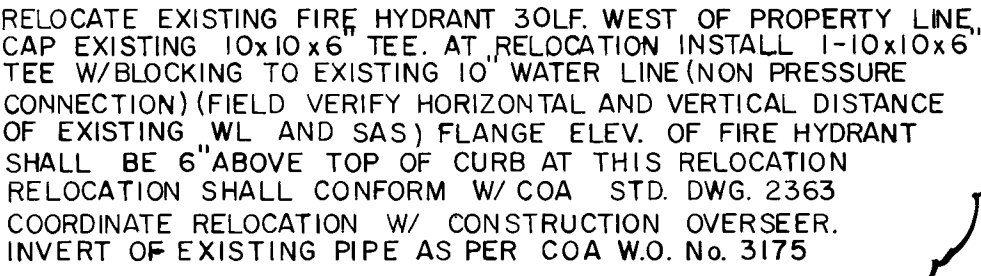

		CITY OF ALBUQUERQUE PUBLIC WORKS DEPARTMENT ENGINEERING GROUP			
TITLE: SYCAMORE PLAZA WATER & SANITARY SEWER PLAN & PROFILE LINE D					
APPROVALS	ENGINEER	DATE	APPROVALS	ENGINEER	DATE
DRG CHAIRMAN	<i>B.P. Goodley</i>	<i>11-6-92</i>	WATER	<i>R.W. Kane</i>	<i>10-28-92</i>
TRANSPORTATION	<i>N/A RAG</i>	<i>10-20-92</i>	WASTE WATER	<i>R.W. Kane</i>	<i>10-28-92</i>
HYDROLOGY	<i>N/A RAG</i>	<i>10-30-92</i>			

DRAWING NO. 4555.90	MAP NO. E&F 19820	SHEET 10 OF 12
-------------------------------	----------------------	------------------------------

