
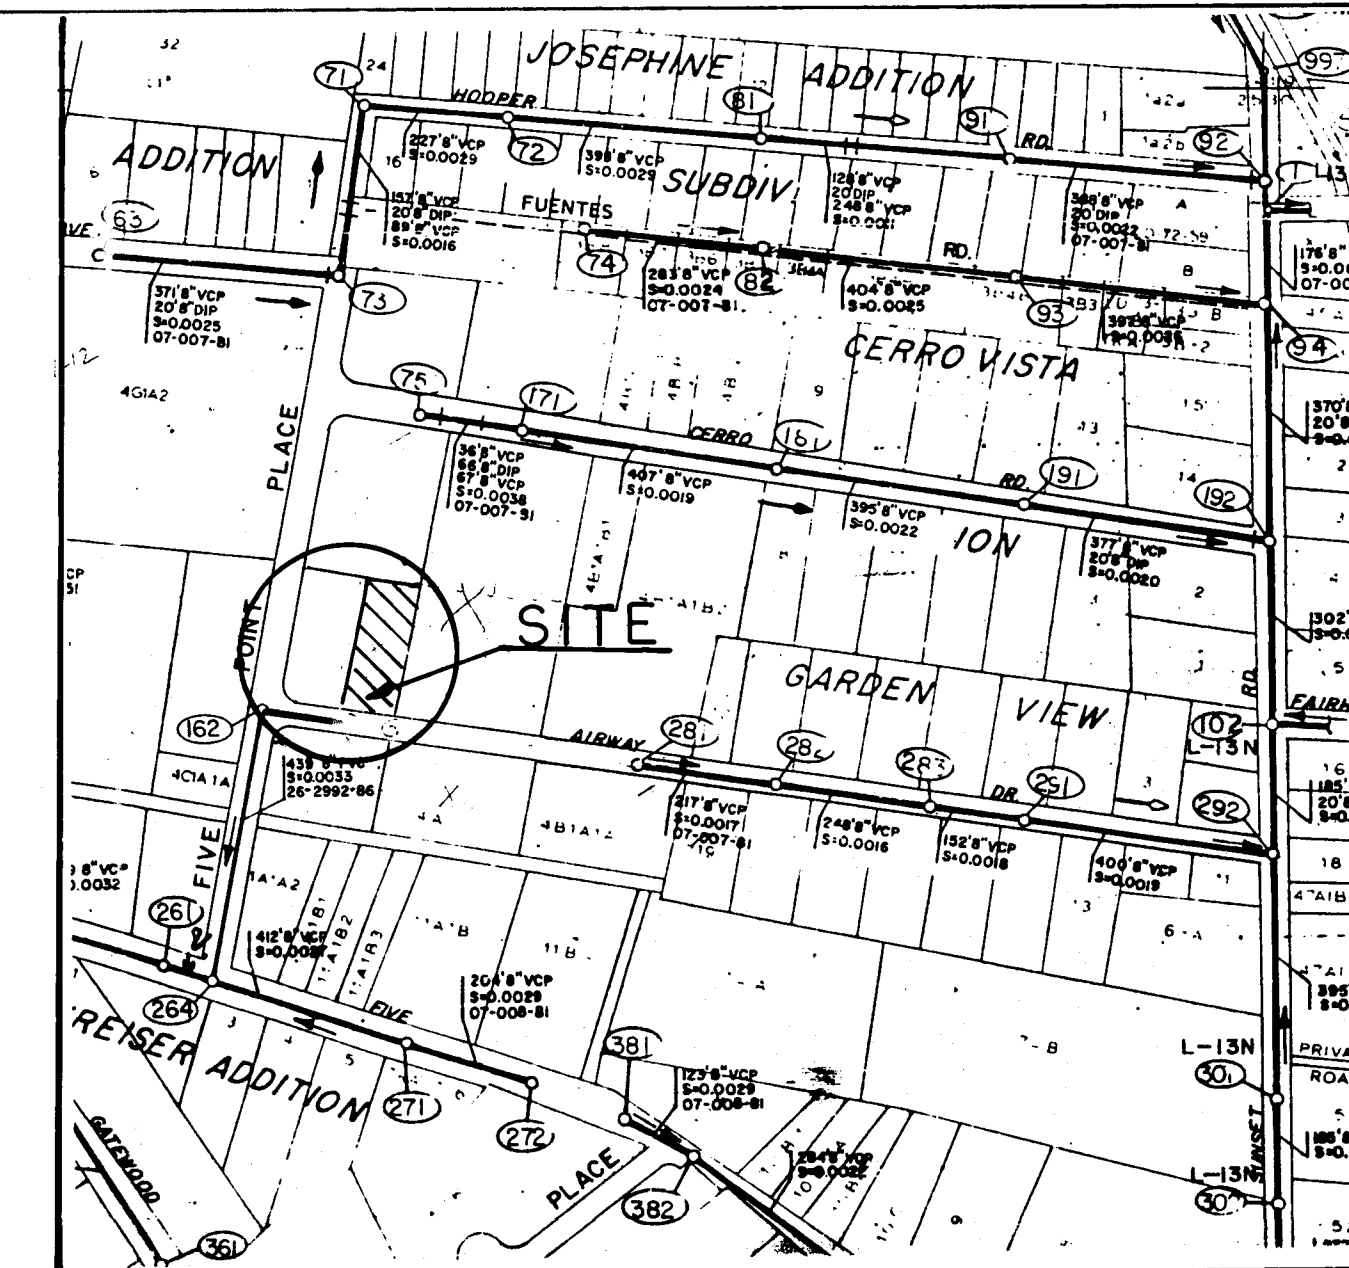
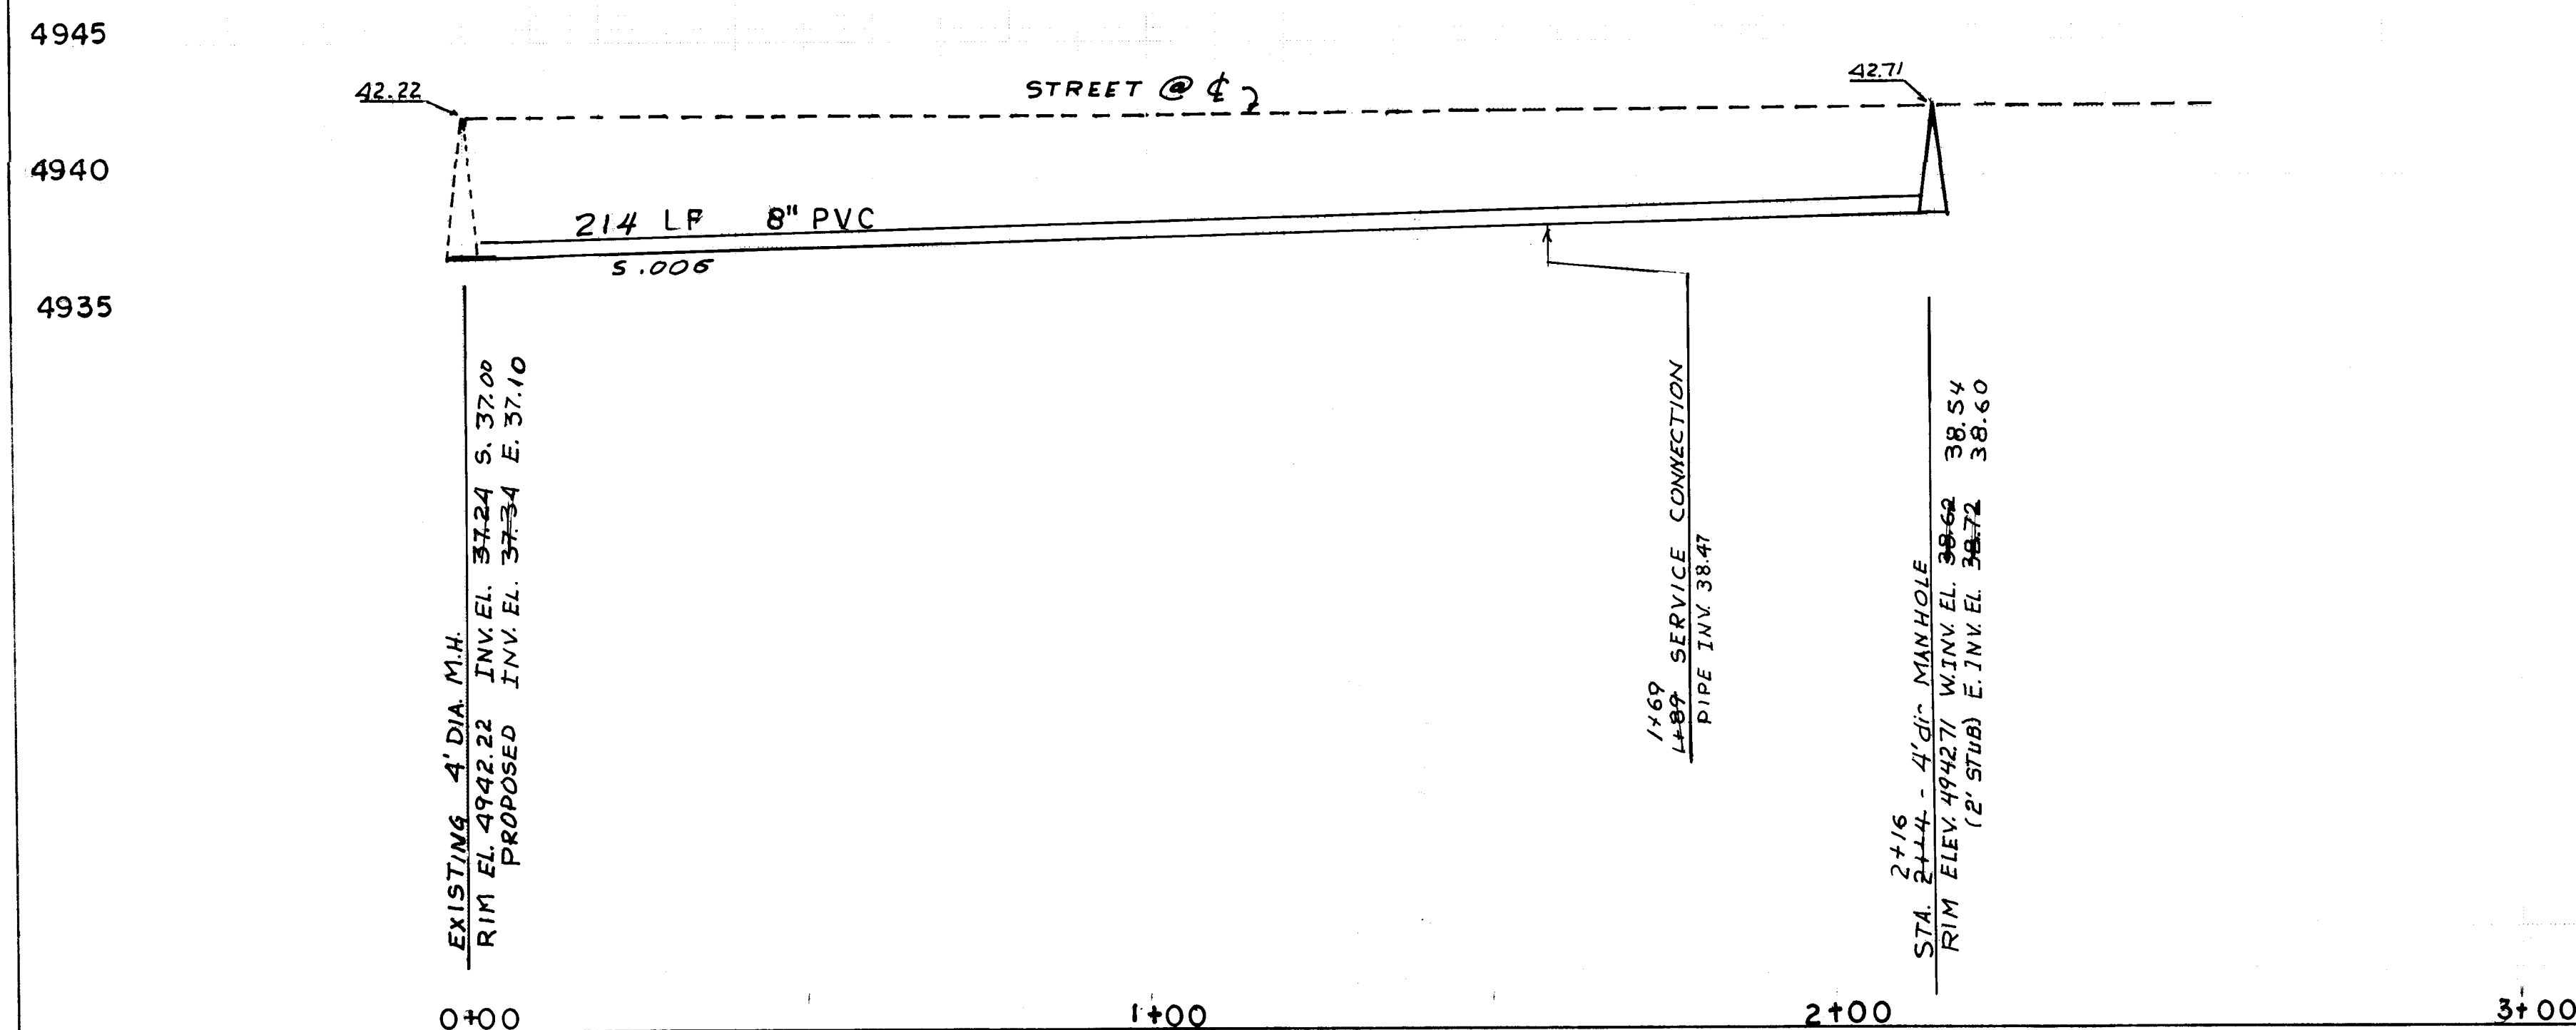


POWER, TELEPHONE & CABLE
LINES ARE ABOVE GROUND

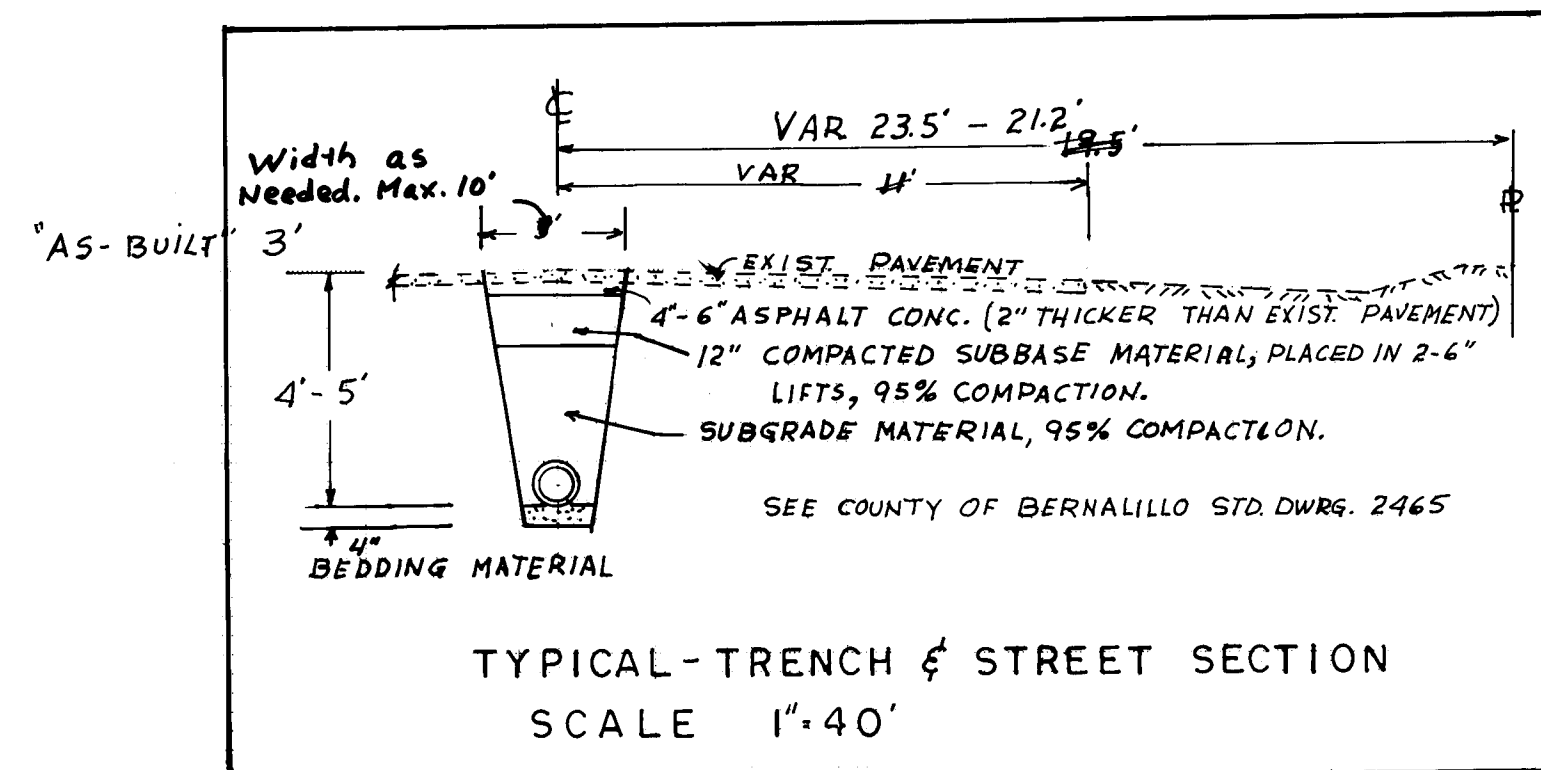

LOCATION MAP

ZONE ATLAS L-12

NOTES

1. STATIONS ARE STREET CENTERLINE STATIONS.
2. TYPE "C" MANHOLE SHALL BE INSTALLED AS PER CITY STD. DRAWING 2101.
3. SEWER SERVICE CONNECTIONS SHALL BE INSTALLED AS PER CITY STANDARD DRAWING NO. 2125.
4. WATER AND GAS LINES SHALL BE INSTALLED AS PER SUPPLEMENTAL GENERAL CONDITION SECTION 181, POLICY ON PROXIMITY OF WATER AND GAS LINES; N.M. STANDARD SPECIFICATIONS.
5. This project is subject to the terms & conditions of the Master Utility Easement & Right-of-Way Agreement entered into between the County of Bernalillo & the City of Albuquerque, effective date 8-20-1990.

NOTICE TO CONTRACTOR

1. ALL WORK DETAILED ON THESE PLANS TO BE PERFORMED UNDER CONTRACT SHALL, EXCEPT AS OTHERWISE STATED OR PROVIDED FOR HEREON, BE CONSTRUCTED IN ACCORDANCE WITH THE CITY OF ALBUQUERQUE STANDARD SPECIFICATIONS FOR PUBLIC WORKS CONSTRUCTION, 1986.
2. TWO (2) WORKING DAYS PRIOR TO ANY EXCAVATION, CONTRACTOR MUST CONTACT NEW MEXICO ONE-CALL SYSTEM, INC., 260-1998, FOR LOCATION OF EXISTING UTILITIES.
3. PRIOR TO CONSTRUCTION, THE CONTRACTOR SHALL EXCAVATE AND VERIFY THE HORIZONTAL AND VERTICAL LOCATIONS OF ALL OBSTRUCTIONS. SHOULD CONFLICT EXIST, THE CONTRACTOR SHALL NOTIFY THE ENGINEER OR SURVEYOR SO THAT THE CONFLICT CAN BE RESOLVED WITH A MINIMUM AMOUNT OF DELAY.
4. ~~TRAFFIC CONTROL~~
~~THREE (3) WORKING DAYS PRIOR TO BEGINNING CONSTRUCTION THE CONTRACTOR SHALL SUBMIT TO THE CONSTRUCTION COORDINATION DIVISION A DETAILED CONSTRUCTION SCHEDULE. TWO (2) WORKING DAYS PRIOR TO CONSTRUCTION THE CONTRACTOR SHALL OBTAIN A BARRICATING PERMIT FROM THE CONSTRUCTION COORDINATION DIVISION. CONTRACTOR SHALL NOTIFY BARRICADE ENGINEER (768-2551) PRIOR TO OCCUPYING AN INTERSECTION. SEE SECTION 19 OF THE SPECIFICATIONS. ALL STREET STRIPING ALTERED OR DESTROYED SHALL BE REPLACED IN KIND BY THE CONTRACTOR TO LOCATION AND IN KIND AS EXISTING OR AS INDICATED BY THIS PLAN SET.~~
5. INSPECTION REQUIRED:
APPLICANT REQUIRED TO OBTAIN PERMITS FROM G.J. FOSTER AT BERNALILLO COUNTY PUBLIC WORKS DEPARTMENT. Ph. 843-6120

LEGAL

LOT 8-2 OF THE REPLAT OF LOT "B" OF
BLEA'S OF REPLAT OF TRACT 4-C-1-B-1
M.R.G.C.D. MAP 42, BERNALILLO COUNTY
NEW MEXICO.

ADDRESS

1591 AIRWAY DRIVE S.W.
ALBUQUERQUE NM 87105

ENGINEER'S SEAL		SURVEY INFORMATION		BENCH MARKS		AS BUILT INFORMATION	
		FIELD NOTES					
NO.	DATE	BY	DATE	BM. EL. 4942.22 - TOP RIM AT EXISTING MANHOLE • INTERSECTION OF FIVE POINTS PLACE & AIRWAY DRIVE S.W.		CONTRACT WITH ROBERTS PLUMBING	
		R.A. RIVERA	2-93			DRAWN BY RA. RIVERA DATE 7/93	
REVISIONS						FIELD	
DESIGN						REVISIONS BY RA. RIVERA DATE 7/93	
						CORRECTED BY RA. RIVERA DATE 8/93	
						MICRO-FILM INFORMATION	
						RECORDED BY DATE	
						NO	
DESIGNED BY RAR		DATE 2-19-93				RD. & HOOPER RD. SW - ALUM. disk TOP OF CONCRETE SLAB.	
DRAWN BY "		DATE "					
CHECKED BY		DATE					
		2-19-93					

APPROVAL OF AS BUILT DRAWINGS
CHIEF CONSTRUCTION ENGINEER
Russell B. G. Miller
DATE *8-25-93*

APPROVED FOR
CONSTRUCTION
Ricardo B. Lopez 7/13/93
CITY ENGINEER DATE

12 13 14 15
 RIVERA ENGINEERING
 2624 Valencia Dr. N.E.
 Albuquerque, NM 87110
 Phone 881-3419

CITY OF ALBUQUERQUE
PUBLIC WORKS DEPARTMENT
ENGINEERING GROUP

TITLE AIRWAY DRIVE S.W.
SEWER — PLAN AND PROFILE

APPROVALS	ENGINEER	DATE	APPROVALS	ENGINEER	DATE
DRC CHAIRMAN	<i>A. J. Sordley</i>	3-30-93	WATER	<i>R.W. Kame</i>	3-30-93
TRANSPORTATION	<i>NARHO</i>	3-30-93	WASTE WATER	<i>R.W. Kame</i>	3-30-93
HYDROLOGY	<i>WA SAR</i>	3/30/93	<i>BCPWD</i>	<i>Charles R. Brown</i>	3/18/93

PROJECT NO.	4627.90	MAP NO.	L-12	SHEET	1	OF	1
-------------	---------	---------	------	-------	---	----	---