

NOTE: TRANSITION FROM STD. CURB TO MOUNTABLE CURB PER STD. DWG. 2418
MOJAVE ST. = STD. CURB
MOJAVE CT. = MOUNTABLE CURB

1	58.20	57.86
2	58.09	
3	59.00	58.33

Δ = 89°57'39"
R = 25.00'
T = 24.98'
L = 39.25'

STA. 10+18.92, 38.98' LT. TO STA. 10+18.98, 39.02' RT. MAKE NEAT CUT IN EXIST. PAVEMENT 1' FROM GUTTER LIP. REMOVE EXIST. PAVEMENT, CURB & GUTTER & SIDEWALK. INSTALL VALLEY GUTTER PER STD. DWG. 2420.

STA. 10+12.92
1 - WET CONNECTION TO EXIST. MH

STA. 10+37.21, 10' RT. REMOVE EXISTING 8" CAP. INSTALL
8 LF 8" PVC WL
1 - 8" GATE VALVE
W/TYPE "A" BOX
1 - 8"x6" TEE
APPROX 6 LF 6" PVC WL
1 - FIRE HYDRANT, 4"
BURY PER STD. DWG. 2340
FLANGE ELEV. = 5158.47
1 - 8"x4" REDUCER
157 LF 4" PVC
W/ RESTRAINED JOINTS
TC

1	57.69	57.02
2	57.22	
3	57.76	57.42

Δ = 90°02'21"
R = 25.00'
T = 25.02'
L = 39.29'

SANITARY SEWER SERVICE TABLE 4" LINE PER STD. DWG. 2125				
STATION	LEGTH LF	INV. @	REMARKS	
10+75 LT.	23	51.90	W/RISER	
10+90 RT.	23	52.00	W/RISER	
11+60 LT.	38	52.60	W/RISER	
11+65 RT.	40	52.70	W/RISER	
11+85 NW	45	53.20	RADIAL	
11+85 NE	45	53.20	FROM MH	

WATER SERVICE TABLE (3/4") PER STD. DWG. 2362				
STATION	LEGTH LF	TYPE	REMARKS	
11+15 LT.	30	SINGLE		
11+20 RT.	11	DOUBLE		
11+95 LT.	54	DOUBLE		
12+00 RT.	33	SINGLE		

CUL-DE-SAC DATA (CLOCKWISE)				
PT	TC	STATION & OFFSET	DELTA	
1	59.04	11+53.32 24.00' LT.	35°46'57"	
2	59.24	11+73.40 38.18' LT.	35°46'57"	
3	59.49	11+97.97 37.95' LT.	35°46'57"	
4	59.67	12+17.77 23.39' LT.	35°46'57"	
5	59.76	12+25.32 00.00	35°46'57"	
6	59.67	12+17.77 23.39' RT.	35°46'57"	
7	59.49	11+97.97 37.95' RT.	35°46'57"	
8	59.24	11+73.40 38.18' RT.	35°46'57"	
9	59.04	11+53.32 24.00' RT.	35°46'57"	
R = 40.00' L = 24.98' (BETWEEN PNTS)				

STA. 11+85.32
INSTALL
1 1/4" DIA. TYPE "E" MH
RIM ELEV. = 5159.02
INV (S) = 49.00

LENGTH RESTRAINED PIPE		
DESCRIPT.	PIPE SIZE	LEGTH LF
TEE	8"	47
VALVE	8"	82
HYDRANT	6"	62
REDUCER	8"x4"	113

TBM - "C" CUT IN CURB,
LOCATED ON THE SOUTH SIDE
OF MOJAVE ST., 240' WEST
OF Q. OF POJOAQUE DRIVE.
ELEVATION = 5152.89.


MOJAVE COURT N.W.

TESUQUE DRIVE N.W.



SANITARY SEWER SERVICE TABLE 4" LINE PER STD. DWG. 2125				
STATION	LEGTH LF	INV. @	REMARKS	
11+15 RT.	30	61.7	W/RISER	
12+11 RT.	30	62.2	W/RISER	
12+86 RT.	30	59.8	W/RISER	

WATER SERVICE TABLE (3/4") PER STD. DWG. 2362				
STATION	LEGTH LF	TYPE	REMARKS	
11+30 RT.	30	SINGLE		
12+20 RT.	30	DOUBLE		

SCALE
HORIZ. 1" = 50'
VERT. 1" = 10'

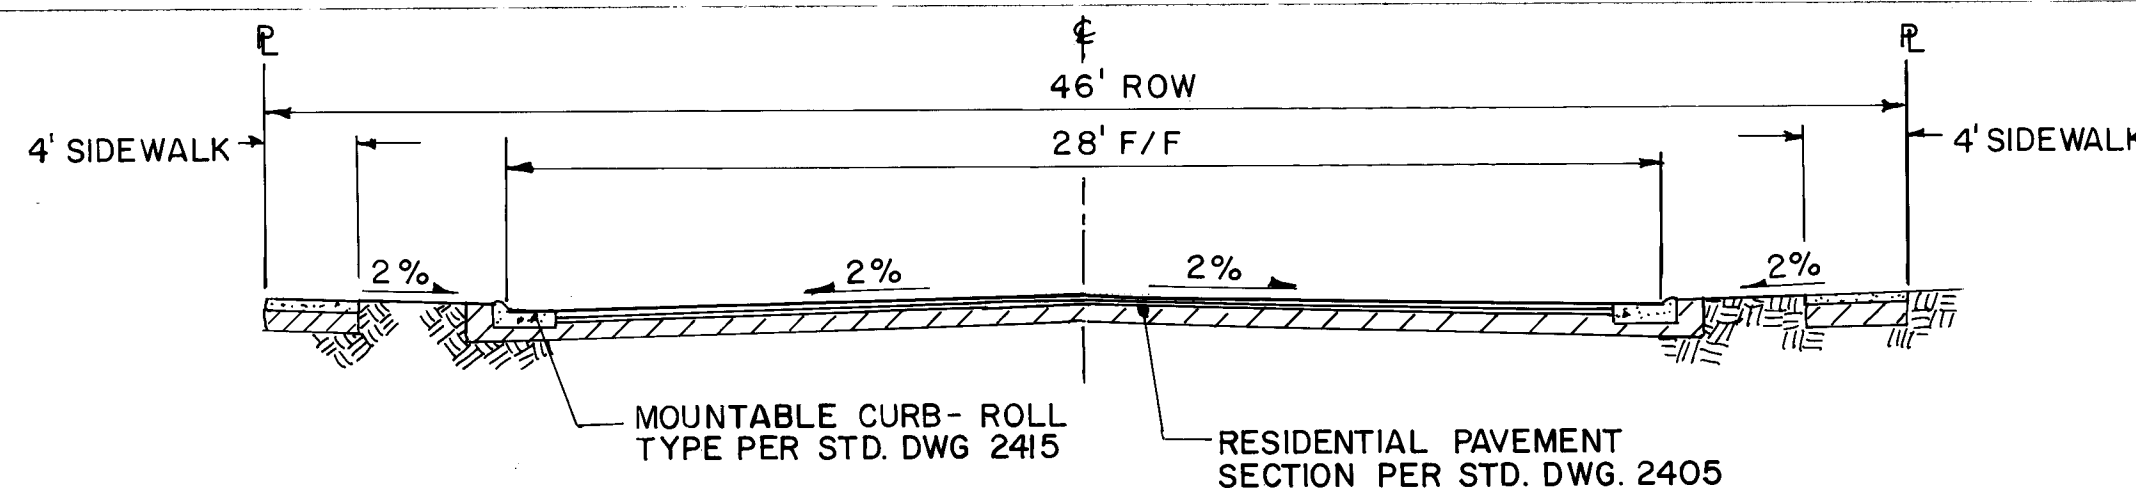

TYPICAL ROADWAY SECTION

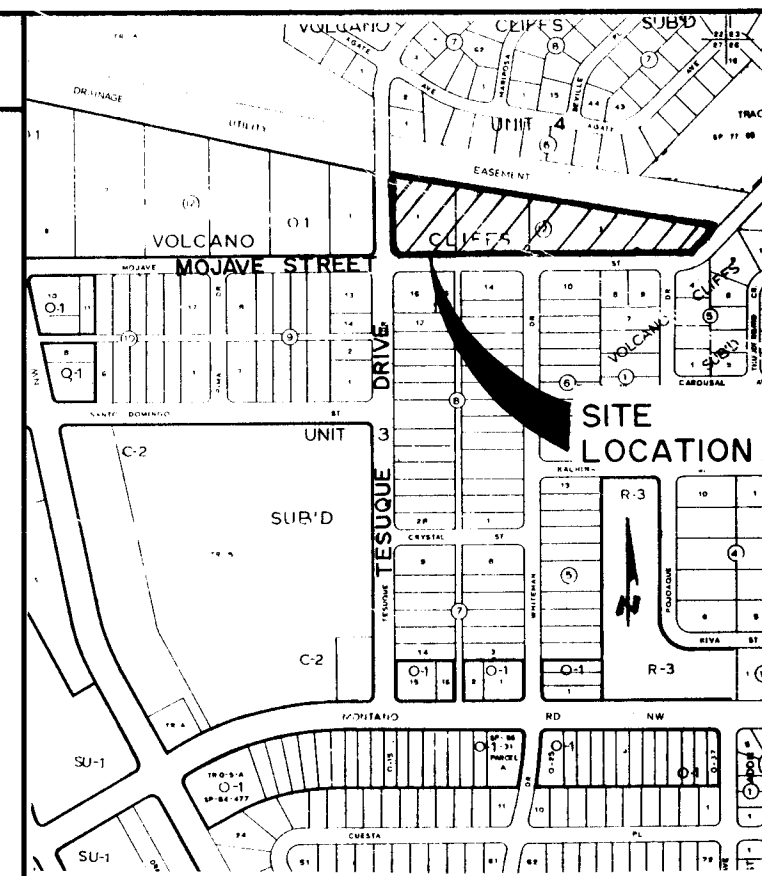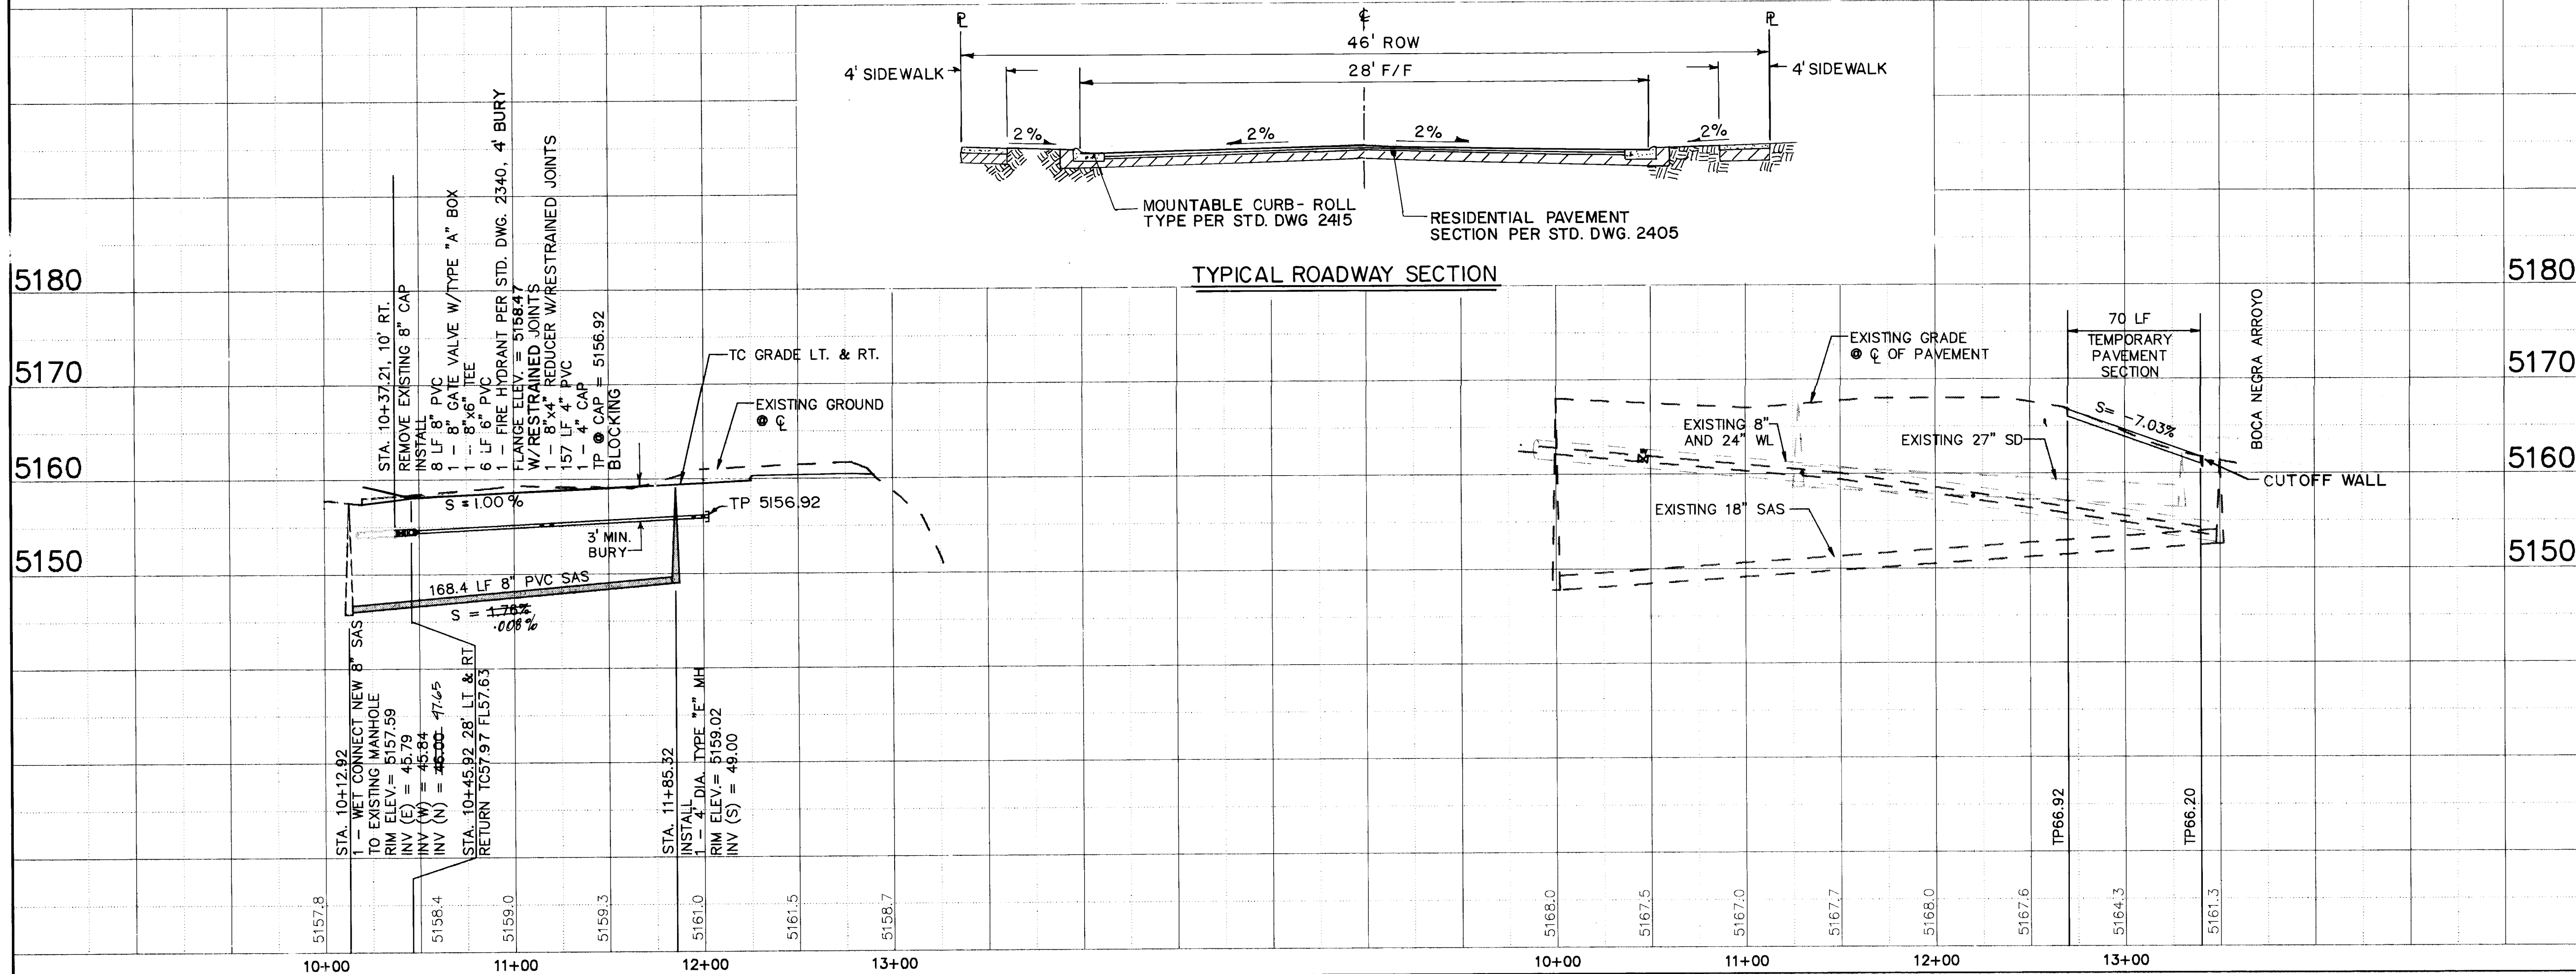

LOCATION MAP
ZONE ATLAS MAP NO. E-10

ALL WORK DETAILED ON THESE PLANS TO BE PERFORMED UNDER CONTRACT SHALL, EXCEPT AS OTHERWISE STATED OR PROVIDED FOR HEREON, BE CONSTRUCTED IN ACCORDANCE WITH THE COA STANDARD SPECIFICATIONS FOR PUBLIC WORKS CONSTRUCTION, 1986 EDITION (REFERRED TO HEREIN AS THE STANDARD SPECIFICATIONS).

TWO (2) WORKING DAYS PRIOR TO ANY EXCAVATION, CONTRACTOR MUST CONTACT LINE LOCATING SERVICE, 260-1990, FOR LOCATION OF EXISTING UTILITIES.

PRIOR TO CONSTRUCTION, THE CONTRACTOR SHALL EXCAVATE AND VERIFY THE HORIZONTAL AND VERTICAL LOCATIONS OF ALL OBSTRUCTIONS. SHOULD A CONFLICT EXIST, THE CONTRACTOR SHALL NOTIFY THE ENGINEER OR SURVEYOR SO THAT THE CONFLICT CAN BE RESOLVED WITH A MINIMUM AMOUNT OF DELAY.

THREE (3) WORKING DAYS PRIOR TO BEGINNING CONSTRUCTION, THE CONTRACTOR SHALL SUBMIT TO THE CONSTRUCTION CO-ORDINATION DIVISION A DETAILED CONSTRUCTION SCHEDULE. TWO (2) WORKING DAYS PRIOR TO CONSTRUCTION, THE CONTRACTOR SHALL OBTAIN A BARRICADING PERMIT. CONTRACTOR SHALL NOTIFY BARRICADE ENGINEER PRIOR TO OCCUPANCY AN INTERSECTION. SEE SECTION 19 OF THE SPECIFICATIONS.

ALL STREET STRIPING ALTERED OR DESTROYED SHALL BE REPLACED BY CONTRACTOR IN LOCATION AND IN KIND AS EXISTING OR AS INDICATED BY THIS PLAN SET.

AS BUILT INFORMATION		BENCH MARKS		SURVEY INFORMATION		ENGINEER'S SEAL	
CONTRACTOR	DATE	CONTRACTOR	DATE	DATE	BY	NO.	REMARKS
City	12/3/92	City	12/3/92	12/3/92	WILSON & COMPANY		DESIGN
DATE	12/3/92	DATE	12/3/92	DATE	DATE	DATE	DATE

APPROVAL OF AS BUILT DRAWINGS
CHIEF CONSTRUCTION ENGINEER
DATE 10-21-93

APPROVED
FOR CONSTRUCTION

City/ENGINEER 5-17-93

CITY OF ALBUQUERQUE
PUBLIC WORKS DEPARTMENT
ENGINEERING GROUP

TITLE: VOLCANO VISTA SUBDIVISION
PAVING AND UTILITY IMPROVEMENTS
PLAN AND PROFILES

APPROVALS	ENGINEER	DATE	APPROVALS	ENGINEER	DATE
DRC CHAIRMAN	B. J. Goodale	4-7-93	WATER	R. W. Kano	3-26-93
TRANSPORTATION	3-30-93		WASTE WATER	R. W. Kano	3-26-93
HYDROLOGY	4-1-93				

PROJECT NO. 4640.90
MAP NO. E-10
SHEET 1 OF 1

WILSON & COMPANY