


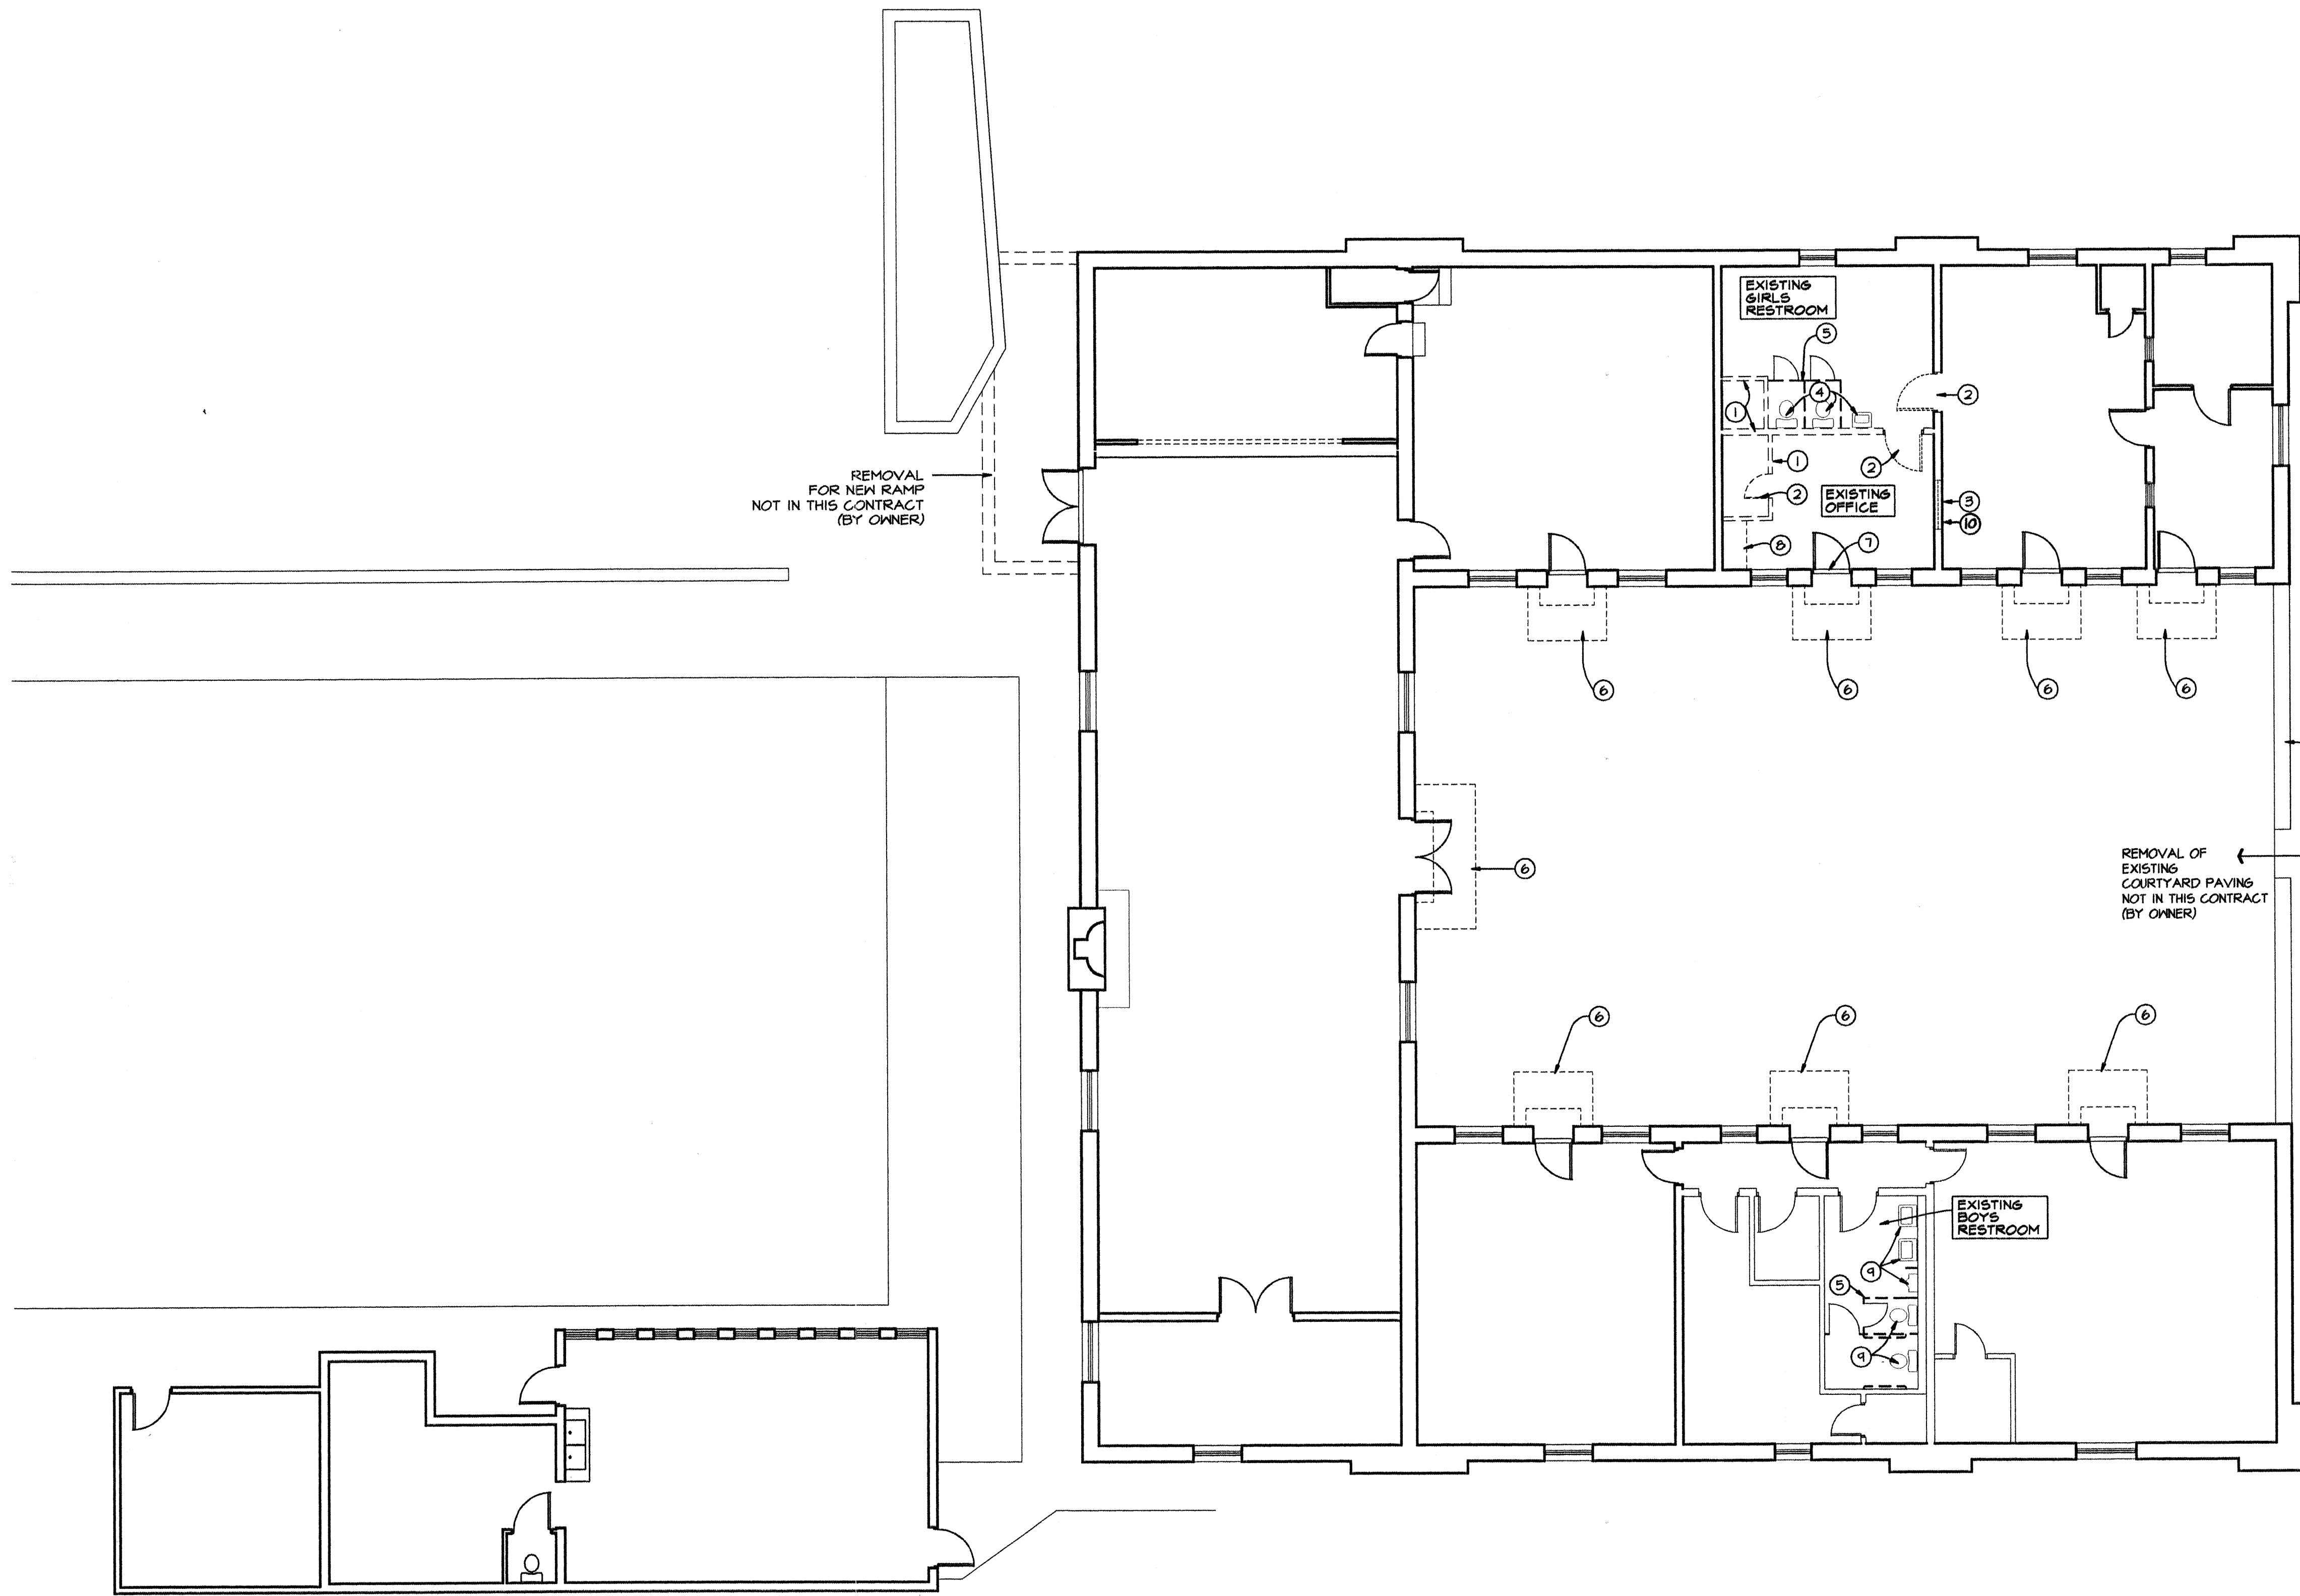

GENERAL NOTES:


- SEE M2-B FOR DUCTWORK REMOVALS.
- SEE M1-B FOR PLUMBING REMOVALS.
- SEE E1-B FOR ELECTRICAL REMOVALS.
- SALVAGE OF ALL PLUMBING AND ELECTRICAL FIXTURES TO OWNER.
- REMOVE MISCELLANEOUS TOILET ACCESSORIES IN BOTH ROOMS AND SALVAGE TO OWNER.

Sheet D1-B: Keyed Note #2, add: Remove door frame as necessary to infill at existing wall. See A2-B.

KEYED NOTES:

- REMOVE EXISTING PARTITION.
- REMOVE EXISTING DOOR. SALVAGE TO OWNER.
- REMOVE EXISTING WINDOW.
- REMOVE EXISTING PLUMBING FIXTURE.
- REMOVE EXISTING TOILET PARTITIONS.
- REMOVAL OF EXISTING DOOR STOOP NOT IN CONTRACT. (BY OWNER).
- REMOVE EXISTING CONCRETE THRESHOLD.
- REMOVE EXISTING CABINETS AND COUNTERTOP. SALVAGE CABINET DOORS TO OWNER.
- REMOVE EXISTING PLUMBING FIXTURE AND CAP SEWER LINES. SEE PLUMBING PLAN M1-B.
- DEMO WALL AT WINDOW FOR NEW DOOR.

EXISTING FLOOR PLAN / DEMOLITION PLAN

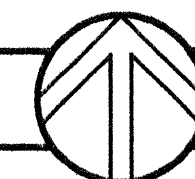

1/8"=1'-0"

CLOUDED AREAS DENOTE "RECORD DOCUMENTS" INFORMATION OBTAINED FROM AS-BUILT DRAWINGS SUPPLIED BY THE GENERAL CONTRACTOR. THE ARCHITECT IS IN NO WAY RESPONSIBLE FOR ACCURACY OF RECORD INFORMATION CONTAINED HEREIN.

GAMELSKY BENTON ARCHITECTS P.C.
822 Tijeras Avenue NW
Albuquerque, NM 87102
TEL (505) 842-8885 FAX (505) 842-1883

FILE
BCC-XFP

CITY OF ALBUQUERQUE
PARKS AND GENERAL SERVICES
DESIGN & DEVELOPMENT DIVISION

TITLE: BARELAS COMMUNITY CENTER
EXISTING FLOOR PLAN / DEMOLITION PLAN

Design Review Committee
APPROVE
JUN 5 1996
DESIGN REVIEW COMMITTEE

City Engineer Approval

City Project No.


4877.91

Zone Map No.


Sheet
D1-B

2 OF 31

NO.		DATE	REVISIONS/REMARKS		BY	SURVEY INFORMATION		BENCH MARK		AS BUILT INFORMATION	
A		8/31/99	AS BUILT INFORMATION		DPL	FIELD NOTES				CONTRACTOR	
						NO.				DATE:	
						BY				WORK STAKED BY	
										DATE:	
										INSPECTOR'S APPROVAL	
										DATE:	
										FIELD VERIFICATION BY	
										DATE:	
										DRAWING CORRECTED BY	
										DATE:	
										MICRO-FILM INFORMATION	
										RECORDED BY	
										DATE:	
										NO.	

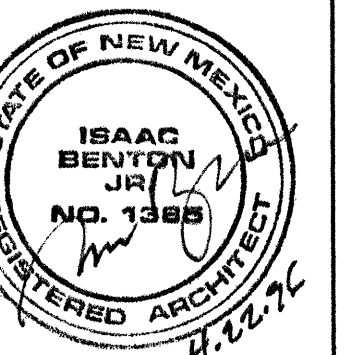

SCANNED BY
MESA REPRO

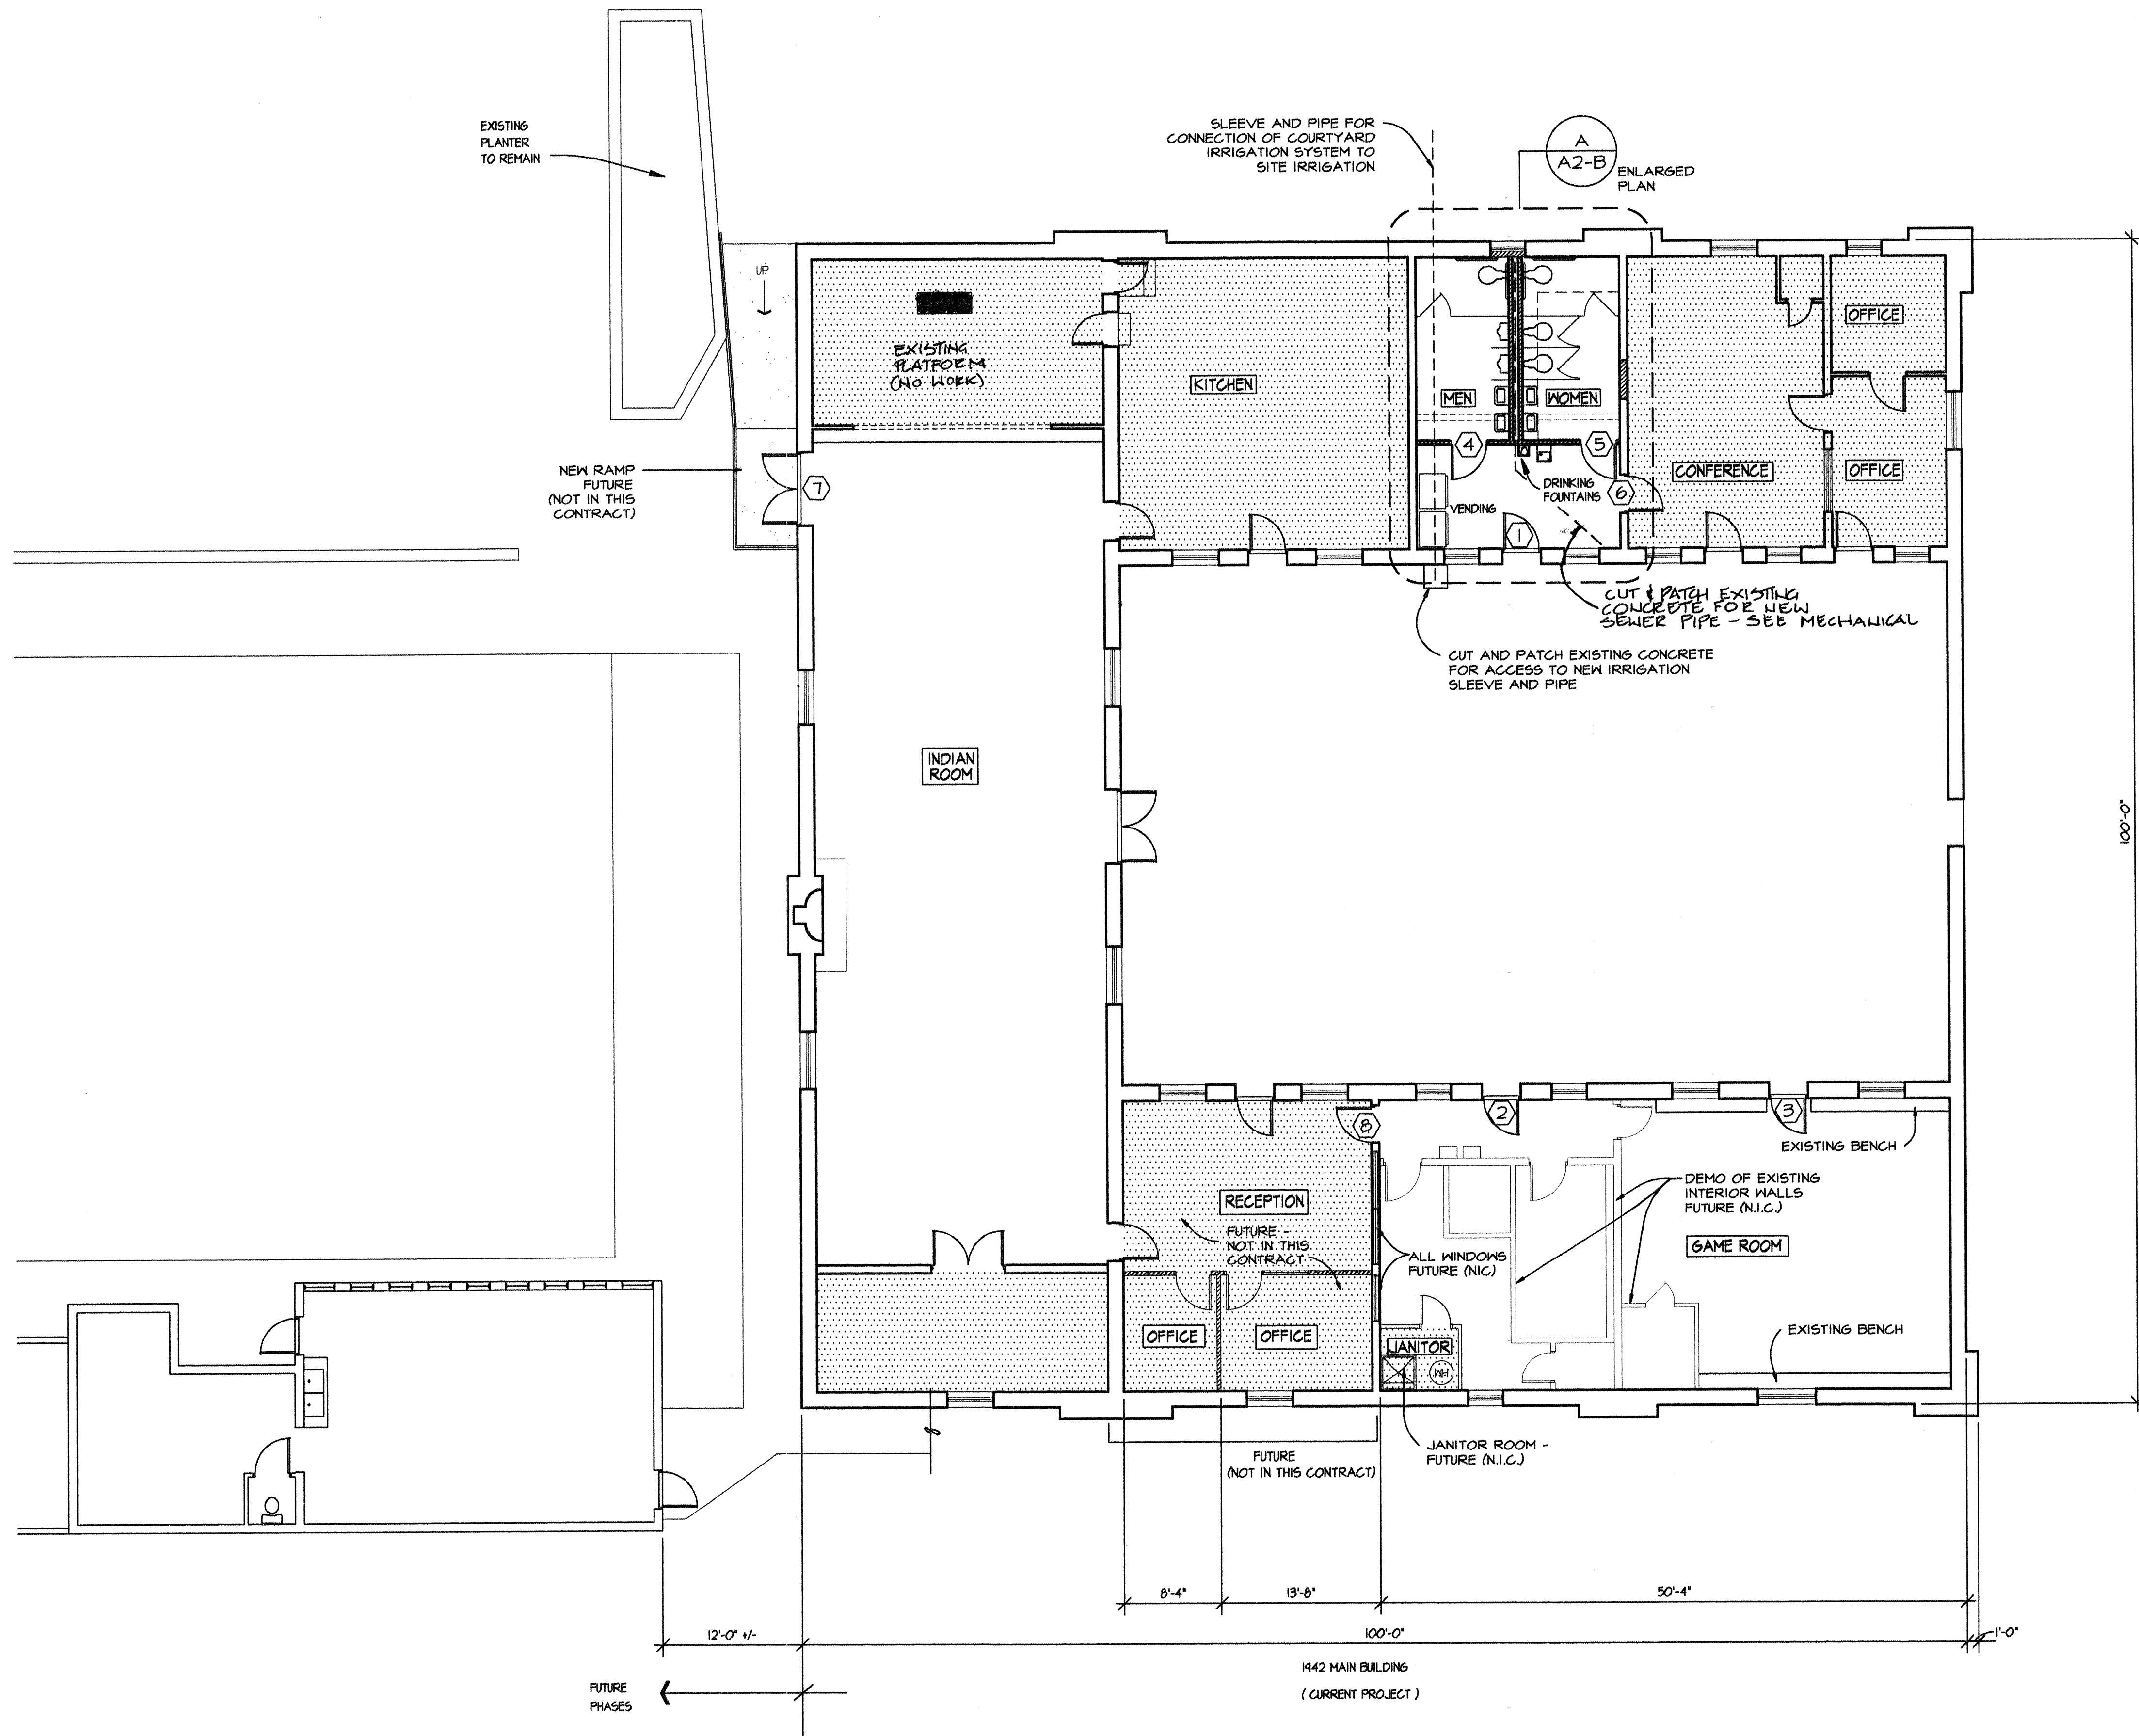

NOTE: SHADED AREAS INDICATE SPACES WHERE NO WORK IS TO BE DONE.

POCHED AREAS INDICATE NEW OR INFILL PARTITION

CLOUDED AREAS DENOTE "RECORD DOCUMENTS" INFORMATION OBTAINED FROM AS-BUILT DRAWINGS SUPPLIED BY THE GENERAL CONTRACTOR. THE ARCHITECT IS IN NO WAY RESPONSIBLE FOR ACCURACY OF RECORD INFORMATION CONTAINED HEREIN.

GAMELSKY BENTON ARCHITECTS P.C.
622 Tijeras Avenue NW
Albuquerque, NM 87102
TEL (505) 842-8865 FAX (505) 842-1693

FILE
BCC-AI

CITY OF ALBUQUERQUE
PARKS AND GENERAL SERVICES
DESIGN & DEVELOPMENT DIVISION

TITLE: BARELAS COMMUNITY CENTER REMODEL

FLOOR PLAN

Design Review Committee

City Engineer Approval

Date	MO./DAY/YR	MO./DAY/YR
	4/19/96	

1/19/96

APPROVE

Upd		

JUN 5 1996

Design		



DESIGN

NAME: _____

DATE: _____

CLASS: _____

TEACHER: _____

East		
------	--	--

City Project No. _____

	Zone Mo
--	---------


No.	Sheet	3 of 31
-----	-------	---------

48

577.91	
--------	--


A-B

SURVEY INFORMATION		BENCH MARK	AS BUILT INFORMATION	
FIELD NOTES			CONTRACTOR	DATE
NO.	BY	DATE	WORK STAKED BY	DATE
			INSPECTOR'S APPROVAL	DATE
			FIELD VERIFICATION BY	DATE
			DRAWING CORRECTED BY	DATE
			MICRO-FILM INFORMATION	
			RECORDED BY	DATE
			NO.	

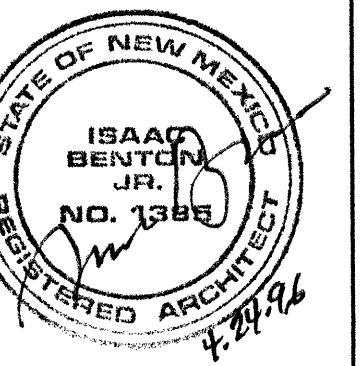
[illegible]

DESIGNED BY: IB	DATE: 4/19/96
DRAWN BY: TB	DATE: 4/19/96
CHECKED BY: IB	DATE: 4/19/96

DESIGNED BY: IB	DATE: 4/19/96
DRAWN BY: TB	DATE: 4/19/96
CHECKED BY: IB	DATE: 4/19/96

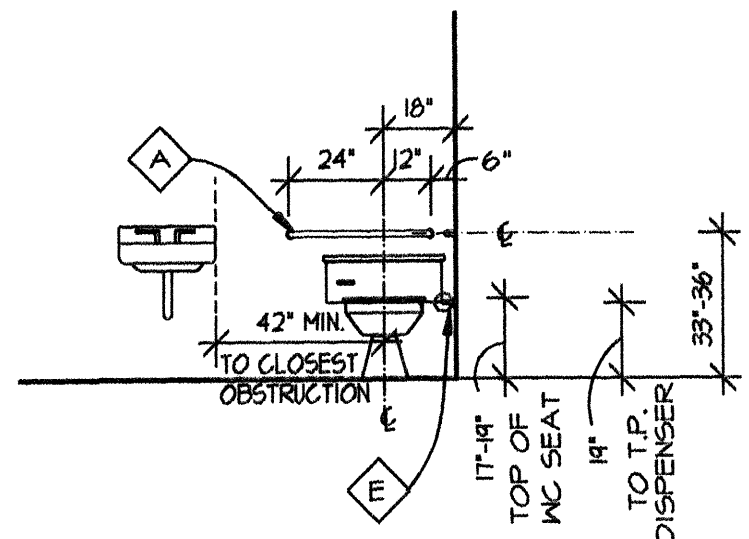


TYPICAL MOUNTING HEIGHTS D 1/4"=1'-0"

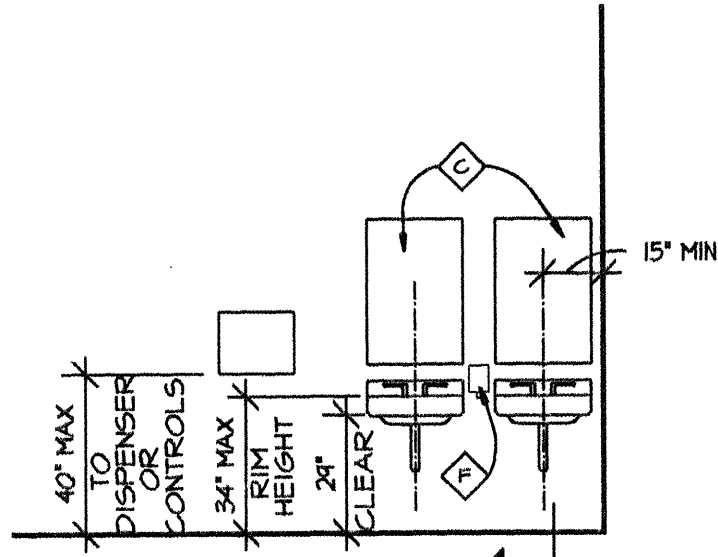


TYPICAL MOUNTING HEIGHTS E 1/4"=1'-0"

NOTE: FOR CLEARANCES AND HEIGHTS ONLY -
FOR ACTUAL ACCESSORY LOCATIONS,
SEE PLAN 'A' THIS SHEET

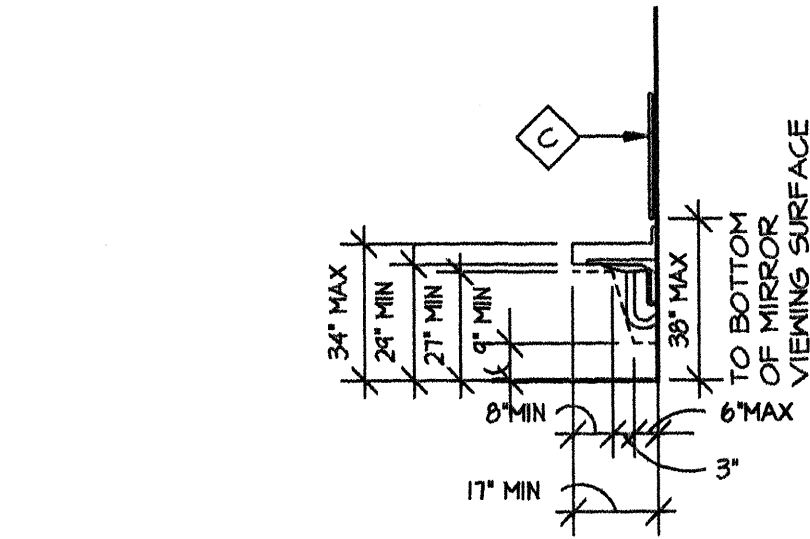


TYPICAL MOUNTING HEIGHTS B 1/4"=1'-0"

PROVIDE INSULATION AT ALL
EXPOSED WATER PIPES

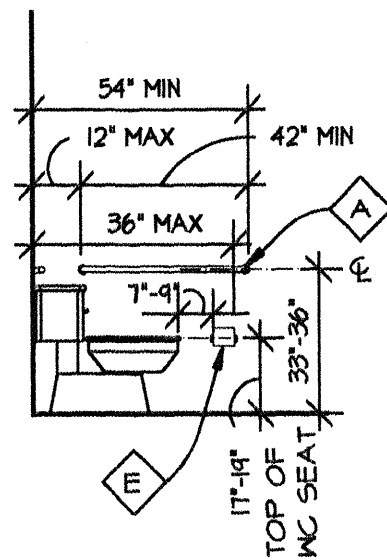

TYPICAL MOUNTING HEIGHTS C 1/4"=1'-0"

GRAB BARS ARE 1 1/2" O.D.

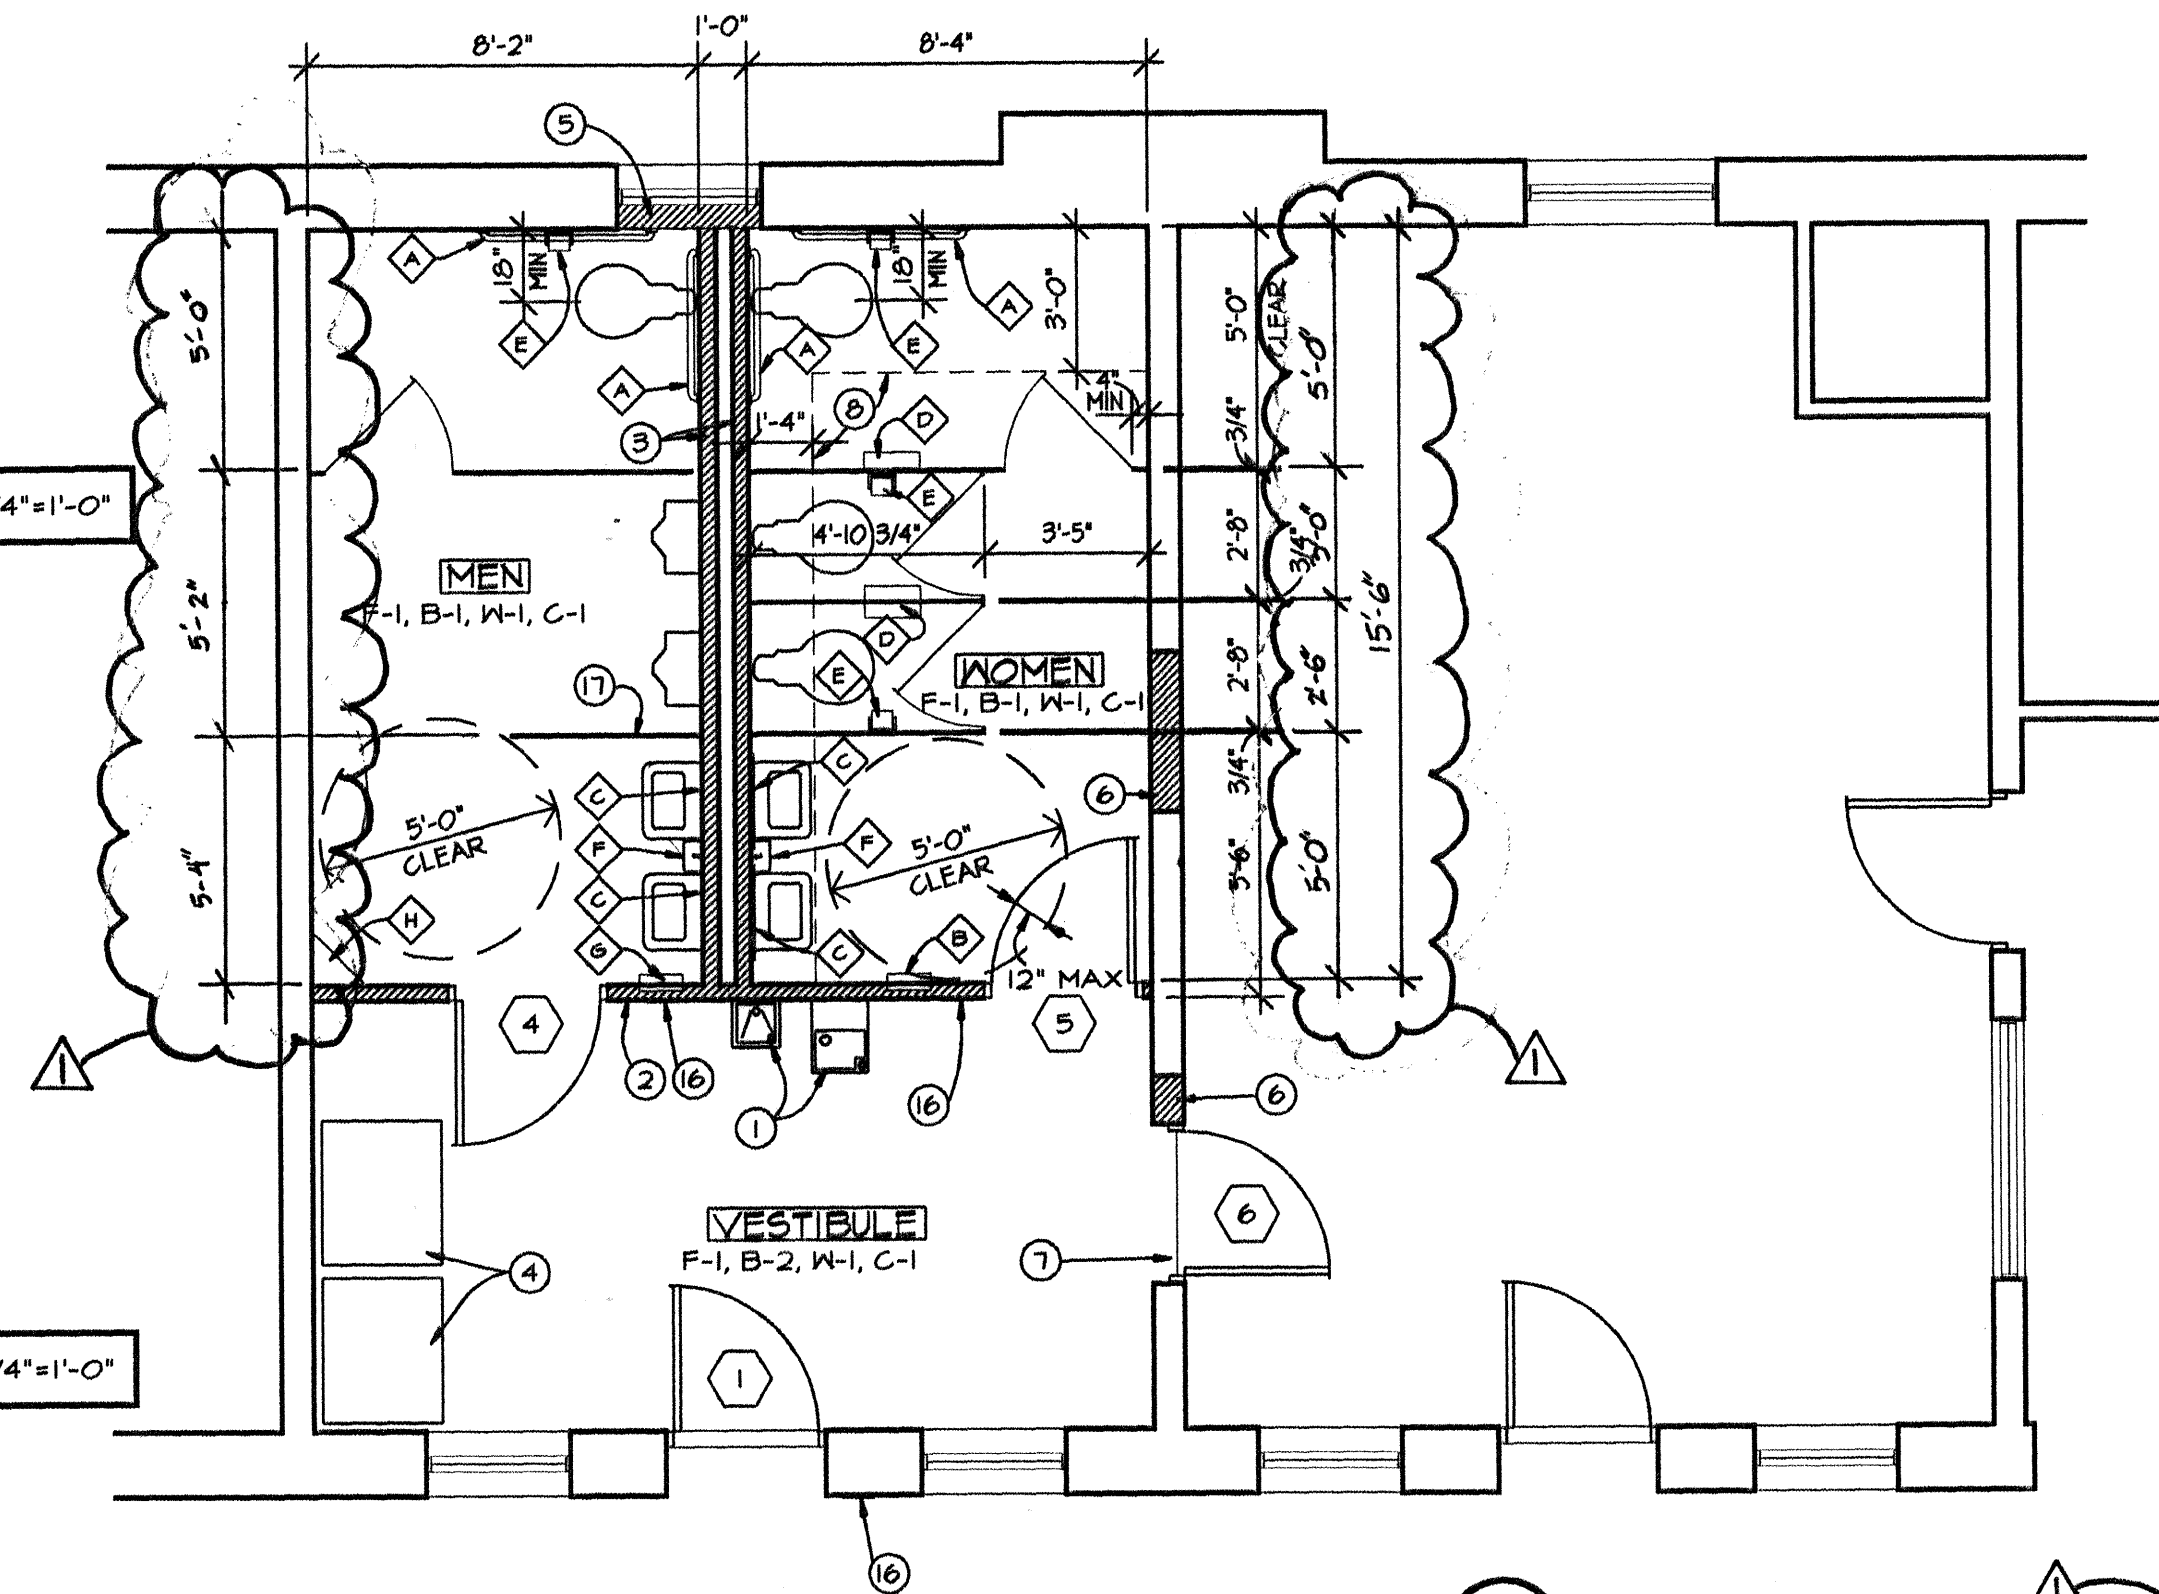

ENLARGED FLOOR PLAN A 1/4"=1'-0"

KEYED NOTES:

1. DRINKING FOUNTAINS. SEE MECHANICAL.
2. TYPICAL PARTITION: 3-5/8" X 256A. STEEL STUDS AT 16" O.C. MAX. 5/8" GYPSUM BOARD EACH SIDE. CONTINUE TO UNDERSIDE OF CEILING AND SEAL TIGHT.
3. CHASE WALL PARTITION: 3-5/8" X 256A. STEEL STUDS AT 16" O.C. WITH 5/8" GYPSUM BOARD ON FINISH SIDE. CONTINUE TO UNDERSIDE OF NEW OR EXISTING CEILING AND SEAL TIGHT.
4. VENDING MACHINES. (NOT IN CONTRACT)
5. INFILL OPENING BEHIND WINDOW: 5/8" GYPSUM BOARD PAINTED FLAT BLACK AT EXTERIOR FACE ATTACHED TO WINDOW FRAME. FURR OUT REMAINDER OF OPENING AND ATTACH 5/8" GYPSUM LATH TO FINISH FLUSH WITH FACE OF EXISTING WALL. PLASTER AND PAINT TO MATCH.
6. INFILL OPENING WITH 25 6A. DRYWALL FRAMING AND GYPSUM LATH. PLASTER AND PAINT TO MATCH EXISTING.
7. REMOVE EXISTING WINDOW AND INSTALL NEW DOOR. PATCH PLASTER AND PAINT TO MATCH EXISTING.
8. FURR DOWN CHASE FOR MECHANICAL DUCT: 3-5/8" X 256A. STEEL STUDS @ 16" O.C. AND 5/8" GYPSUM BOARD. SEE MECHANICAL FOR DEPTH OF DUCT. (MINIMUM 7'-0" ABOVE FINISH FLOOR).
9. CAULK CONTINUOUS BOTH SIDES WITH SEALANT AS SPECIFIED.
10. HOLLOW METAL FRAME.
11. FRAME ANCHOR. INSTALL PER MANUFACTURER'S SPECIFICATIONS.
12. DOOR AS SPECIFIED.
13. EXISTING C.M.U. WALL.
14. THRESHOLD AS SPECIFIED. MAXIMUM HEIGHT 1/2" WITH 45° BEVELED EDGES.
15. THRESHOLD ANCHOR.
16. ACCESSIBILITY SIGNAGE; ONE "MEN", ONE "WOMEN", AND ONE "RESTROOMS" PLASTIC SIGNS WITH RAISED CHARACTERS, GRADE 2 BRAILLE, AND MALE OR FEMALE RAISED PICTOGRAM, MOUNTED 60" A.F.F.
17. URINAL SCREEN (STAINLESS STEEL, 48" WIDE, FLOOR SUPPORTED).

PERIAPPENDIX #2

Keyed Note #8, add: in lieu of gypsum plaster, drywall with round corner bead may be used for infill at Contractor's option. Texture and paint to match existing plaster.

Keyed Note #15, add: Expansion anchors may be used at existing locations in lieu of cast anchor shown.

ACCESSORY SCHEDULE:

- A. GRAB BARS. SEE MOUNTING DETAILS THIS SHEET.
- B. PAPER TOWEL DISPENSER/ DISPOSAL UNIT. (SEMI-RECESSED).
- C. 24" X 36" MIRROR, BOTTOM OF VIEWING SURFACE AT 36" A.F.F.
- D. FEMININE MARKING DISPOSAL UNIT.
- E. TOILET PAPER DISPENSER.
- F. SOAP DISPENSER.
- G. PAPER TOWEL DISPENSER.
- H. CORNER WASTE DISPOSAL UNIT.

ROOM FINISH SCHEDULE:

*NOTE: UNLESS INDICATED OTHERWISE, FIRST FINISH OF EACH ITEM IS TYPICAL THROUGHOUT. INSTALL AT ALL LOCATIONS UNLESS NOTED OTHERWISE. FINISHES THAT VARY FROM TYPICAL ARE NOTED BELOW ROOM NAME ON FLOOR PLAN OR ENLARGED PLAN.

FLOOR
F-1 VINYL COMPOSITION TILE, 12" X 12".


BASE
B-1 6" VINYL COVE.
B-2 4" VINYL COVE.

WALL
W-1 PAINTED DRYWALL.


CEILING
C-1 EXPOSED VIGAS AND WOOD PLANK. PATCH AND TOUCH UP TO MATCH EXISTING STAINED FINISH WHERE WALLS AND FIXTURES HAVE BEEN REMOVED.

DOOR SCHEDULE													
	DOOR					FRAME			REMARKS				
	SIZE	TYPE	DOOR MAT.	DOOR FINISH	GLASS	TYPE	FRAME MAT.	DETAIL	SEE HARDWARE SCHEDULE IN SPECIFICATIONS PATCH AND PAINT EXISTING SCHEDULED DOORS WHERE MODIFIED				
	W	H	T					JAMB	HEAD	SILL			
1	5'-0"	6'-10"	1 5/4"	-	WOOD	EXISTING	-	EXISTING	---	6/A2-B	EXISTING DOOR - ADJUST. REPLACE HARDWARE AND THRESHOLD		
2	5'-0"	6'-10"	1 5/4"	-	WOOD	EXISTING	-	EXISTING	---	6/A2-B	EXISTING DOOR - ADJUST. REPLACE HARDWARE AND THRESHOLD		
3	5'-0"	6'-10"	1 5/4"	-	WOOD	EXISTING	-	EXISTING	---	6/A2-B	EXISTING DOOR - ADJUST. REPLACE HARDWARE AND THRESHOLD		
4	5'-0"	6'-8"	1 5/4"	A	WOOD	CLEAR	-	HOLLOW METAL	K/A2-B	K/A2-B			
5	5'-0"	6'-8"	1 5/4"	A	WOOD	CLEAR	-	HOLLOW METAL	K/A2-B	K/A2-B			
6	5'-0"	6'-8"	1 5/4"	B	WOOD	CLEAR	24" X 60"	HOLLOW METAL	H/A2-B	J/A2-B	1/4" TEMPERED GLASS		
7	PR. 5'-0"	6'-10"	1 5/4"	-	WOOD	EXISTING	-	EXISTING	---	---	EXISTING DOOR - ADJUST. REPLACE HARDWARE AND THRESHOLD		
8	2'-6"	6'-8"	1 5/4"	A	WOOD	EXISTING	-	HOLLOW METAL	---	---			

NOTE: DOOR HARDWARE TO BE TIGHTENED AND READJUSTED ON EXISTING SCHEDULED DOORS. ALL NEW DOOR HARDWARE TO COMPLY WITH A.D.A. AND N.M. BUILDING CODE CHAPTER 31. CLOSERS SHALL BE ADJUSTED SO THAT FROM AN OPEN POSITION (90 DEGREES), TIME REQUIRED TO CLOSE TO 12 DEGREES SHALL BE (5) SECONDS MINIMUM. OPENING FORCE FOR INTERIOR CLOSERS SHALL BE 5.0 LBS. MAXIMUM.

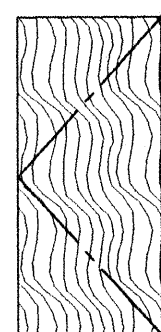


A
FLUSH WOOD

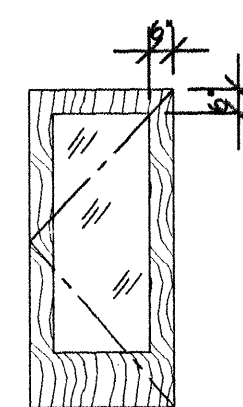


B
WOOD


DOOR TYPES 1/4"=1'-0"

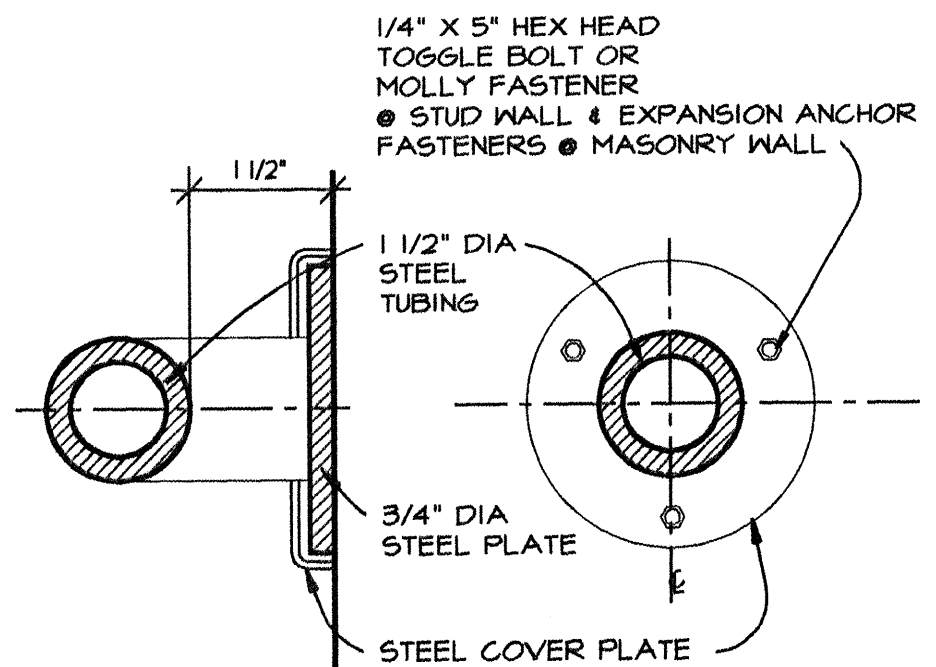


GRAB BAR F HALF SCALE

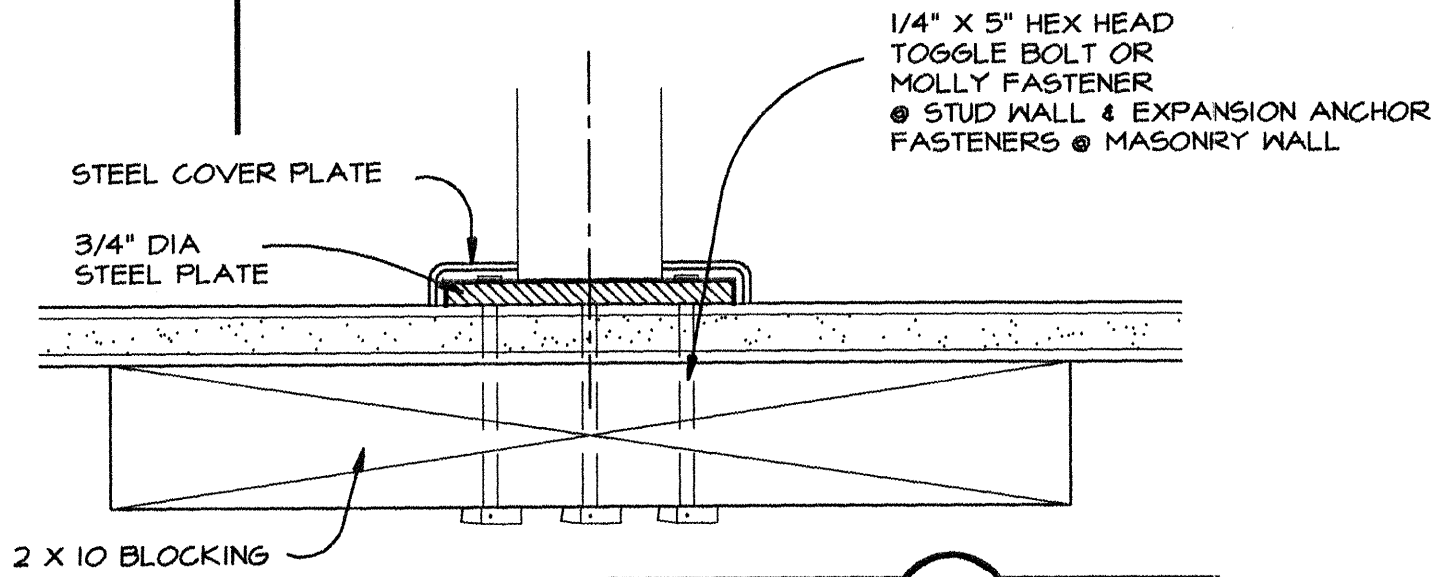


THRESHOLD G 3"=1'-0"

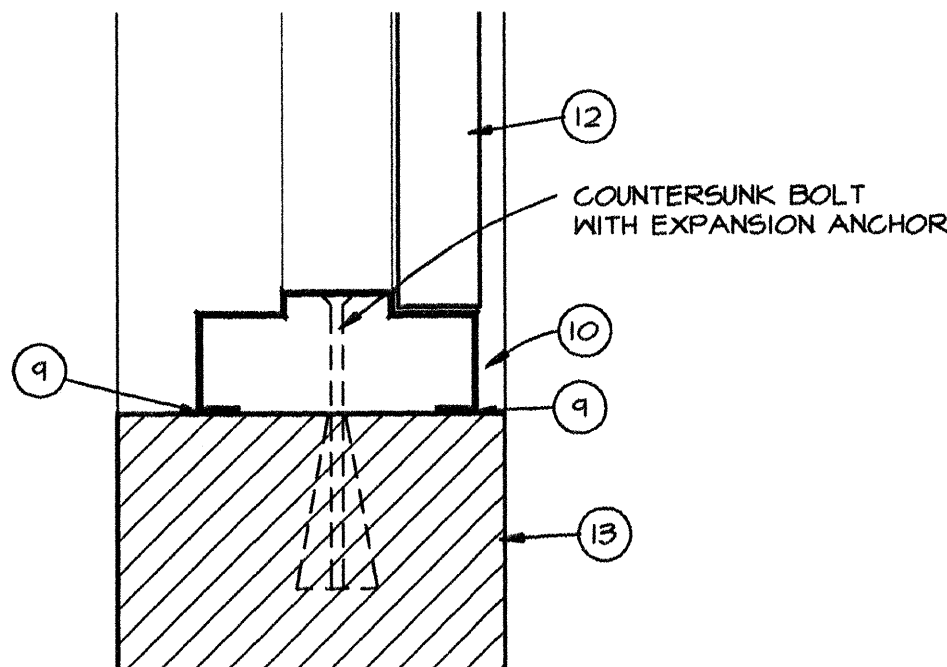


JAMB H 3"=1'-0"

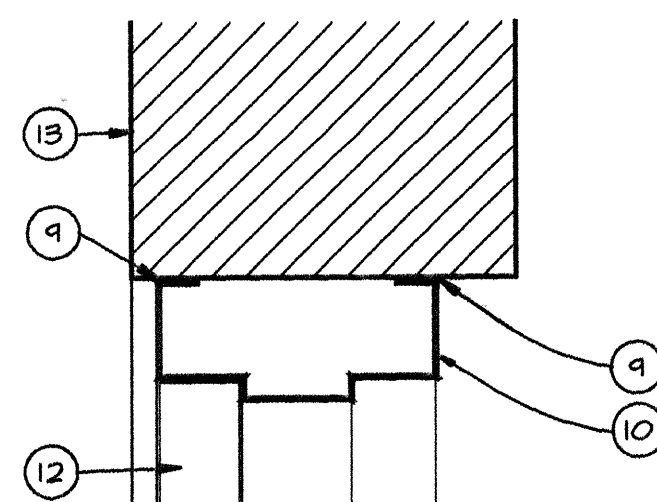

HEAD J 3"=1'-0"

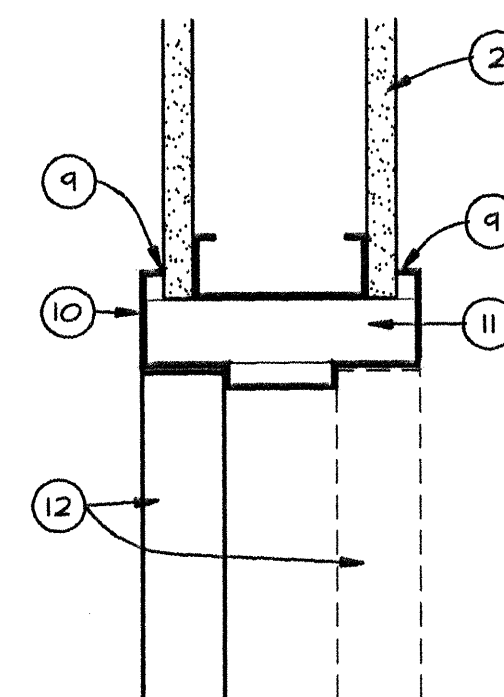

JAMB K 3"=1'-0"
HEAD SIMILAR

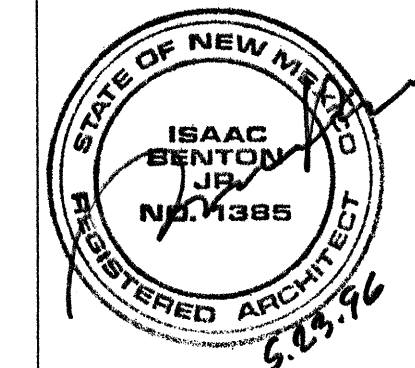

GAMELSKY BENTON ARCHITECTS P.C.
622 Tijeras Avenue NW
Albuquerque, NM 87102
TEL (505) 842-8865 FAX (505) 842-1693



FILE
BCC-A2

CITY OF ALBUQUERQUE
PARKS AND GENERAL SERVICES
DESIGN & DEVELOPMENT DIVISION


TITLE: **BARELAS COMMUNITY CENTER**
ENLARGED FLOOR PLAN / DOOR SCHEDULE / DETAILS

Design Review Committee	City Engineer Approval	MD 7/24/78	MD 7/24/78
APPROVE		4/14/46	
JUN 5 1996			
DESIGN REVIEW COMMITTEE			
City Project No.	Zone Map No.	Sheet	4 of 31
4877.91		A2-B	

PLUMBING FIXTURE SCHEDULE						
MARK	FUNCTION	MANUFACTURER & MODEL	WASTE	VENT	HW	CW
EWC	ELECTRIC WATER COOLER	ELKAY Model EBFA-8 wheelchair access electric water cooler. 8.0 GPH capacity, 1/5 HP, 120V, 1 PH, 60Hz.	1-1/2"	1-1/2"		1/2"
LAV	LAVATORY	AMERICAN STANDARD "Lucerne" 0355.012, vitreous china, wall-mounted lavatory with concealed arm carrier. Include 5401.152V faucet with vandal resistant metal cross handles, 2.0 aerator, grid drain, P-trap & supplies with stops.	1-1/2"	1-1/2"	1/2"	1/2"
LAVH	LAVATORY (HANDICAPPED)	AMERICAN STANDARD "Lucerne" 0355.012 vitreous china, wall-mounted lavatory w/4" faucet center & concealed arm carrier. Include drain & tailpiece, 3/8" supplies w/ stops, P-traps and 5402.172V faucet with wrist blade handles, 2.0 aerator, grid, and strainer. Insulate exposed P-traps and supplies w/ BROCAR TrapWrap kit No. 500R.	1-1/2"	1-1/2"	1/2"	1/2"
URH	URINAL (HANDICAPPED)	AMERICAN STANDARD "Washbrook" 6501.010, 1.0 GPF, vitreous china, wash-out flush action, 3/4" top inlet spud, 2 wall hangers, and 2" outlet connection. Include SLOAN ROYAL 186-1 flush valve. Install with rim 17" A.F.F.	2"	1-1/2"		3/4"
UR	URINAL	AMERICAN STANDARD "Washbrook" 6501.010, 1.0 GPF, vitreous china, wash-out flush action, 3/4" top inlet spud, 2 wall hangers, and 2" outlet connection. Include SLOAN ROYAL 186-1 flush valve.	2"	1-1/2"		3/4"
WC	WATER CLOSET	AMERICAN STANDARD "Cadet II" 2174.139, EL 1.6 GPF vitreous china, elongated, tank type, 1.6 gallon flush toilet with siphon flushing action and 12" rough-in. Include CHURCH 295-C open-front seat less cover, bolt caps, & 3/8" angle supply w/stop.	4"	2"		1/2"
WCH	WATER CLOSET (HANDICAPPED)	AMERICAN STANDARD "New Cadet II Aquameter" 2216.143, 17" high vitreous china, elongated, tank type toilet with 1.6 gallon siphon flushing action and 12" rough-in. Include CHURCH 295-C open front seat less cover & 3/8" supply w/stop. Tank & trip lever shall be right or left hand as req'd by ADA.	4"	2"		1/2"

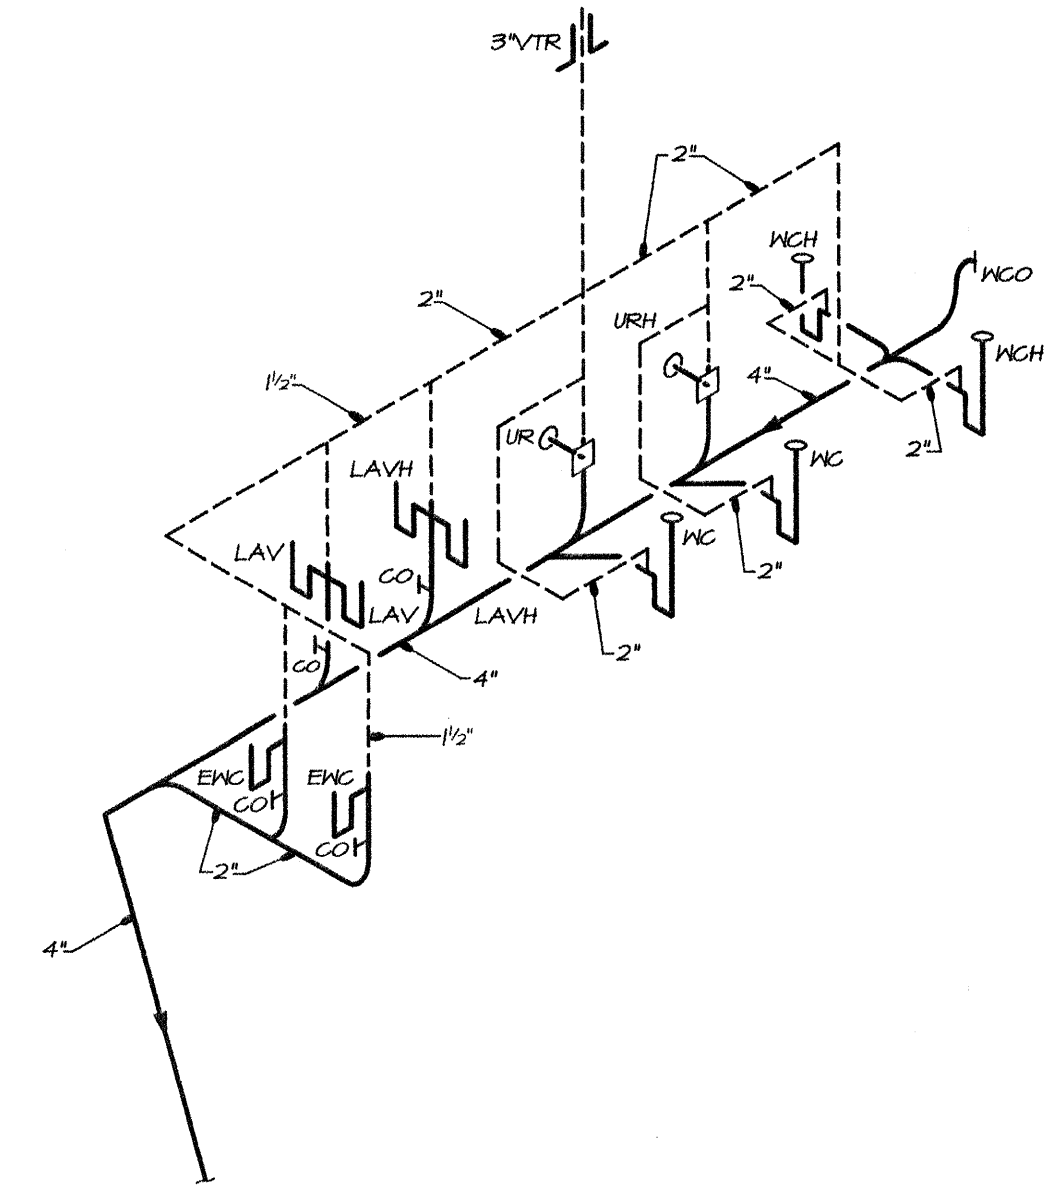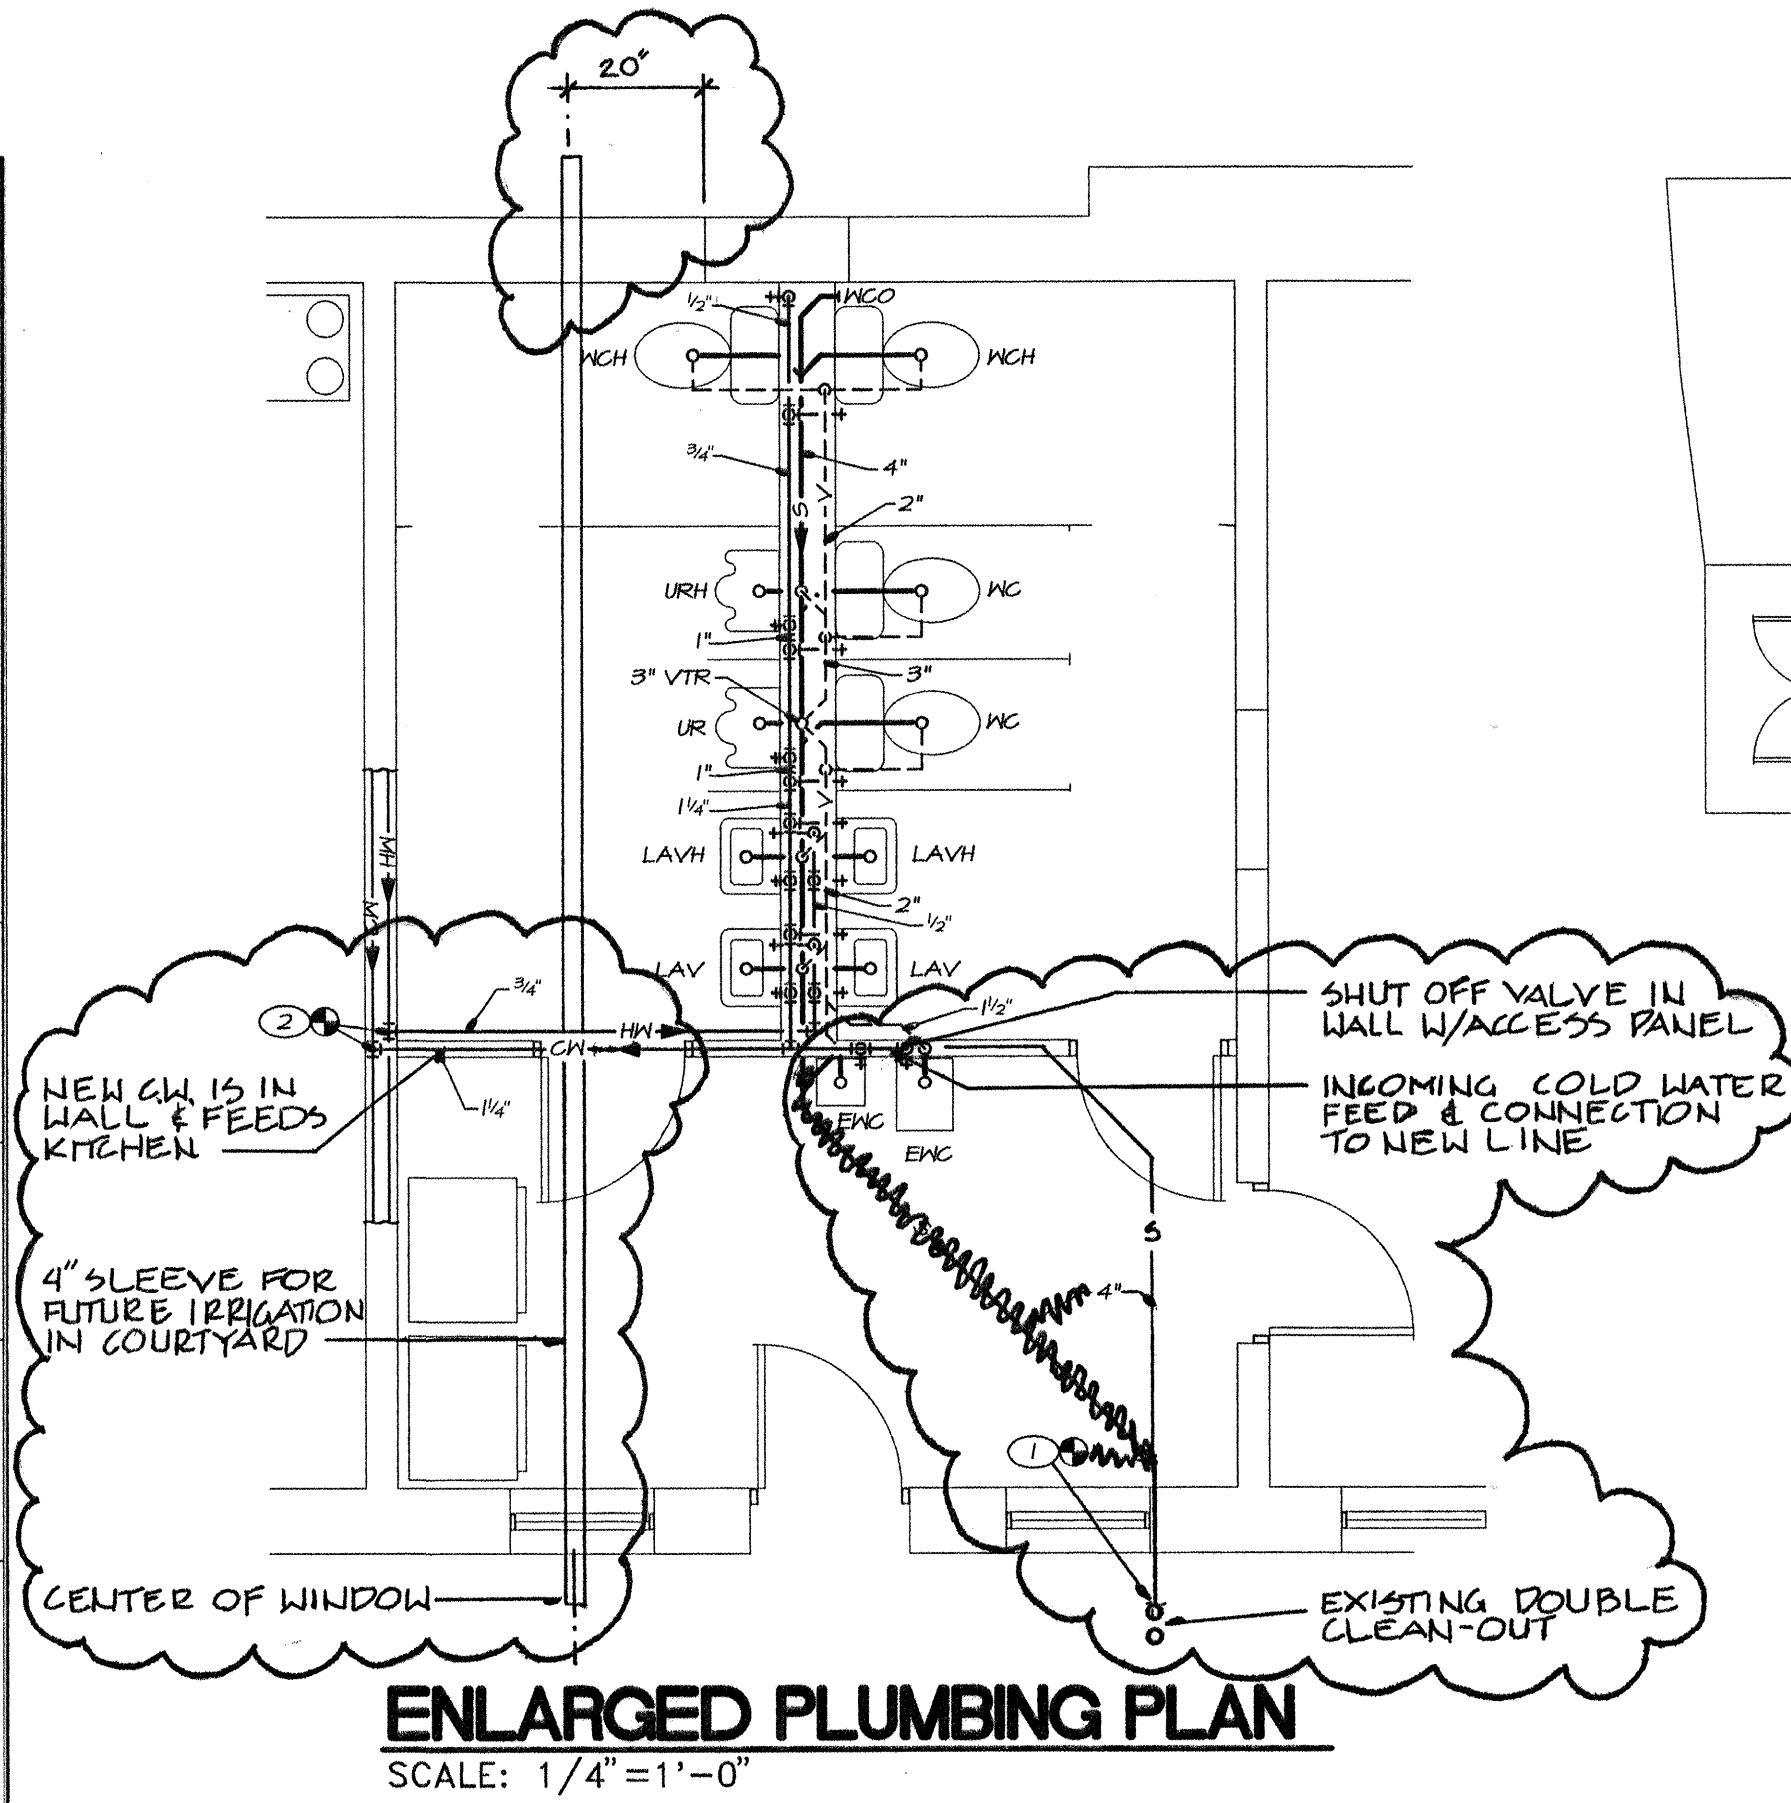

WASTE AND VENT RISER DIAGRAM
NO SCALE

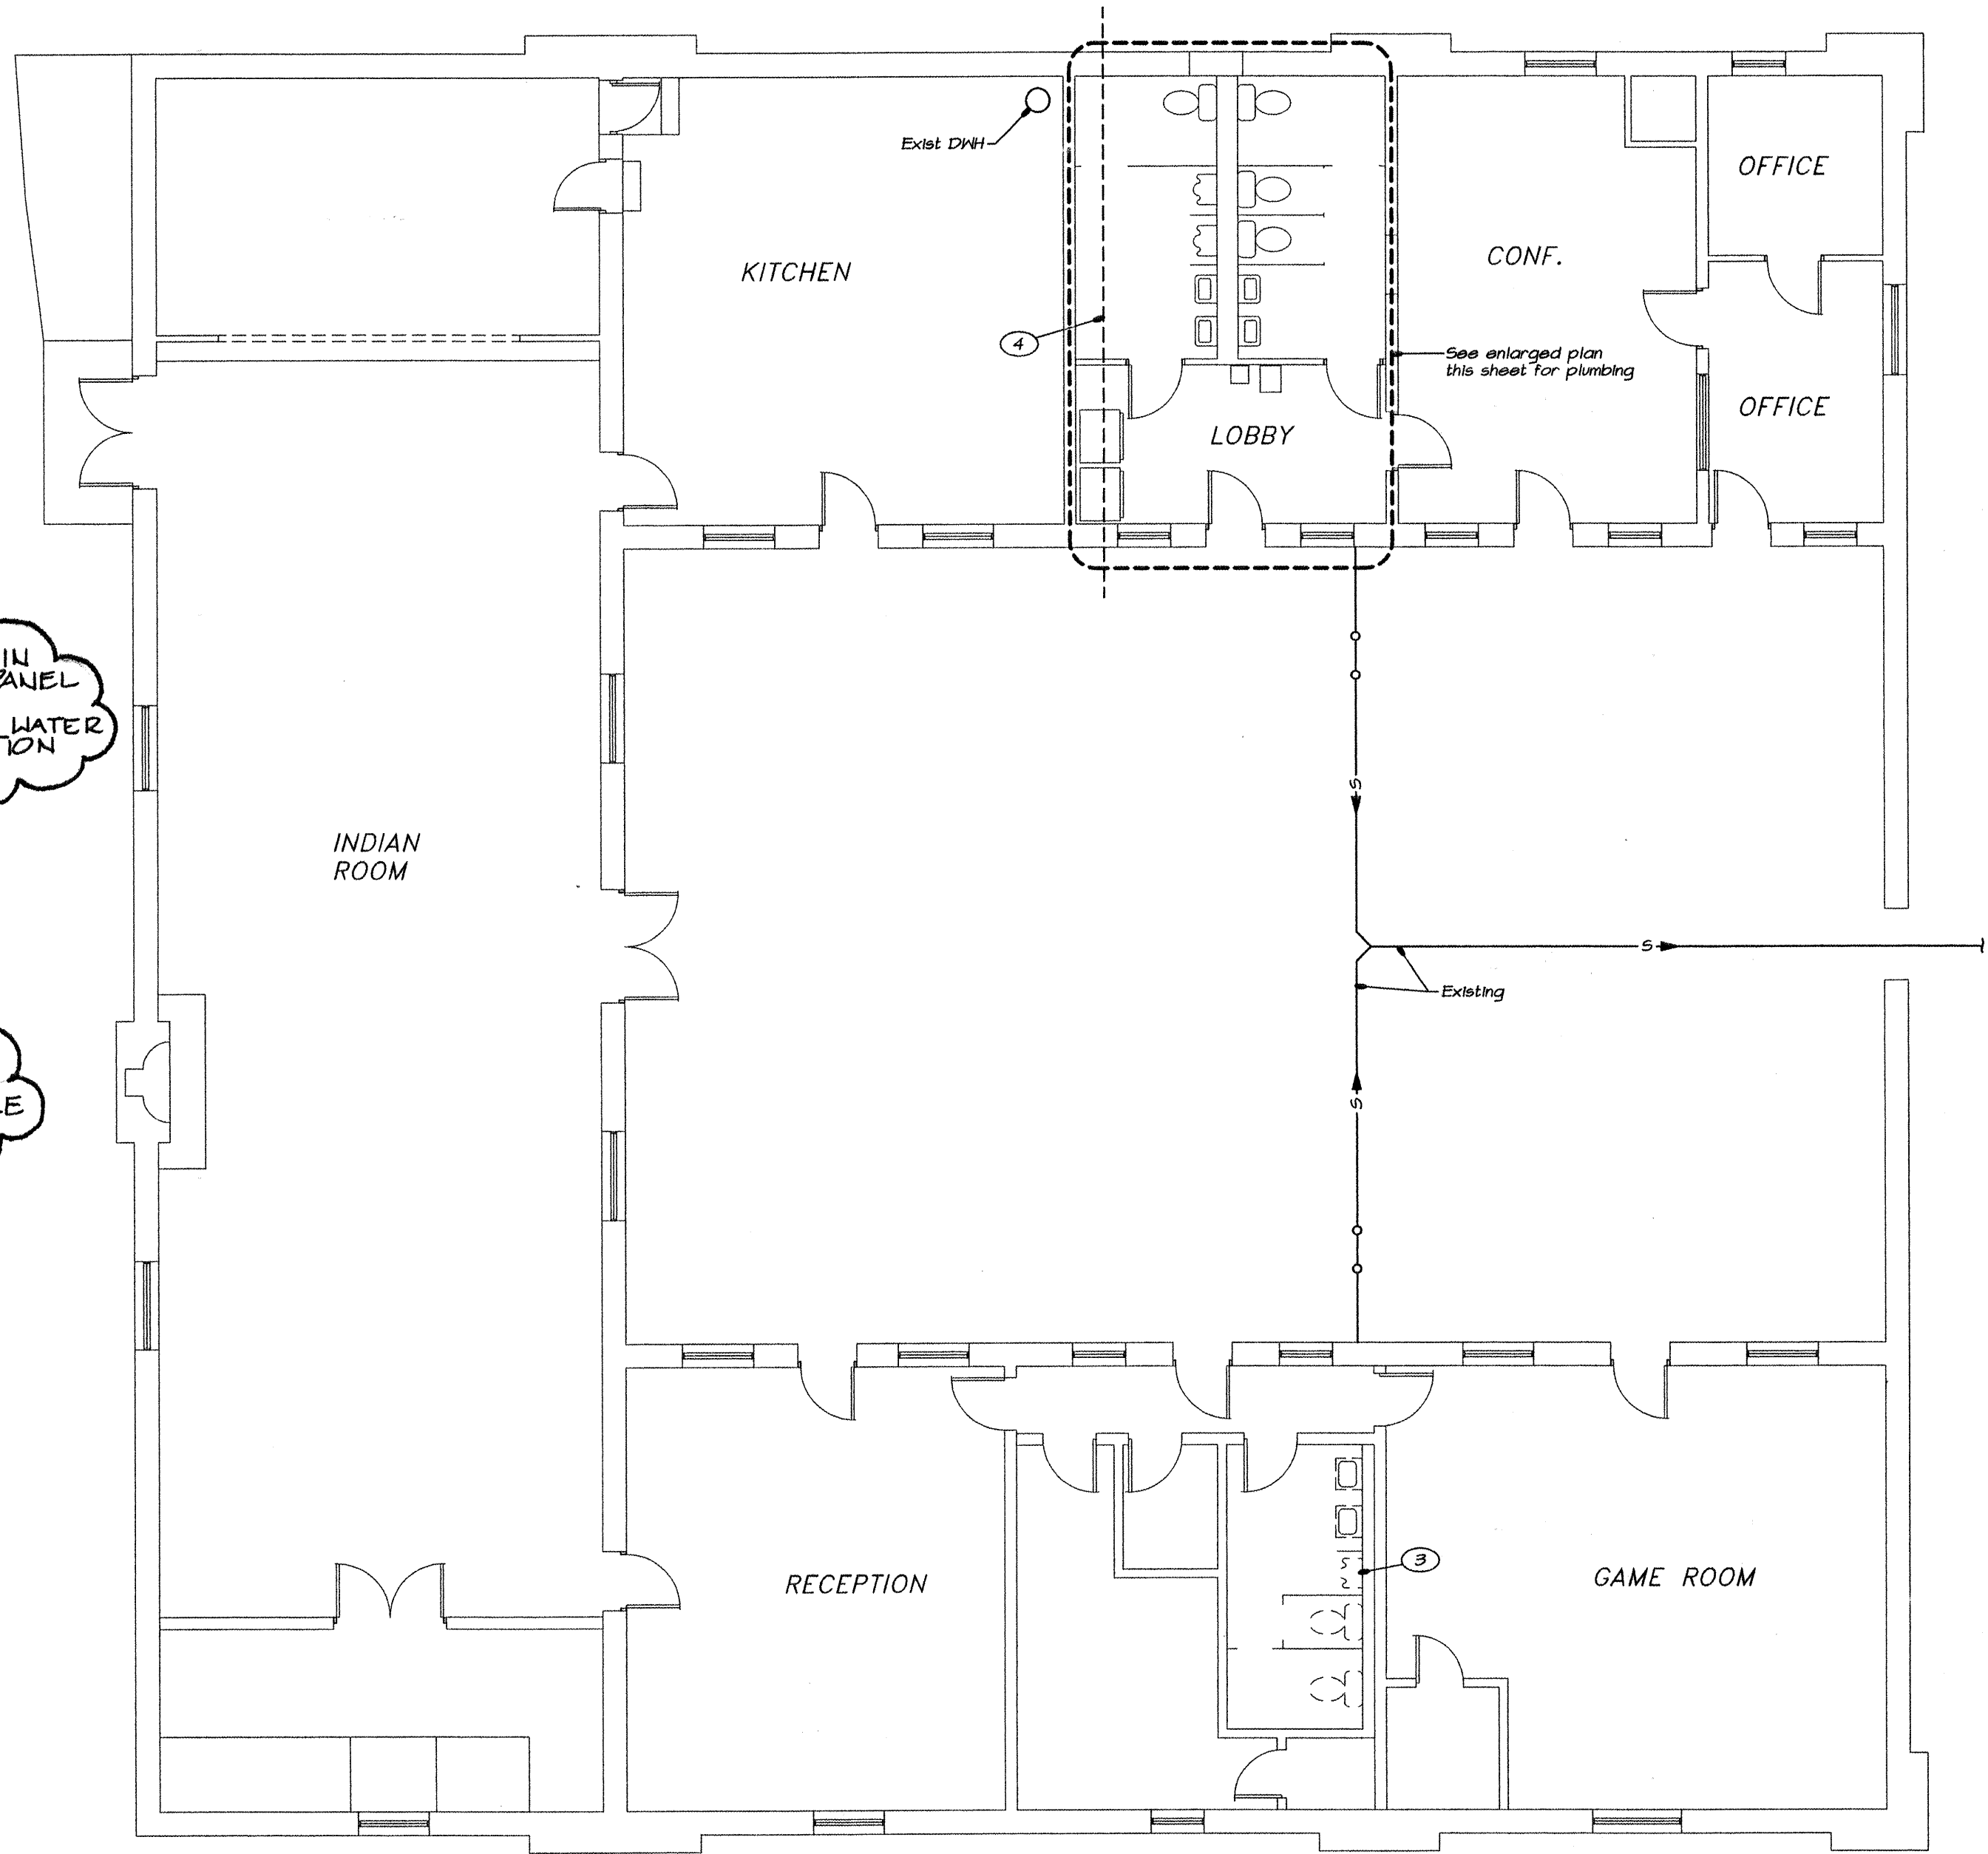

FLOOR PLAN - PLUMBING
SCALE: 1/8" = 1'-0"

KEYED NOTES

- CONNECT TO EXISTING SEWER. CHECK INVERT ON EXISTING SEWER AND VERIFY ADEQUATE SLOPE FOR NEW LINE. ENSURE SEWER LINE FROM KITCHEN REMAINS OPERABLE.
- CONNECT NEW HOT & COLD WATER LINES TO EXISTING LINES IN THIS AREA. ROUTE NEW LINES ACROSS TO PLUMBING CHASE IN WALL, ABOVE DOOR.
- ALL PLUMBING FIXTURES IN THIS AREA SHALL BE REMOVED PER ARCHITECTURAL PLAN. REMOVE PIPING TO BELOW SLAB AND CAP. SAW CUT CONCRETE AS REQUIRED FOR REMOVAL OF PIPES. BACKFILL AND TAMP EXCAVATED AREA PRIOR TO REPAIRING CONCRETE FLUSH WITH EXISTING FLOOR.
- PROVIDE 4" SCH 40 PVC SLEEVE FOR PIPE CHASE OF FUTURE COURTYARD IRRIGATION SYSTEM TO EXISTING SITE IRRIGATION. CORE DRILL FOUNDATION AT EACH END FOR INSTALLATION OF PIPE, AND GROUT GAP AFTERWARD.

GENERAL NOTES

- LOCATIONS OF EXISTING PIPING ARE APPROXIMATE. EXACT LOCATIONS SHALL BE FIELD VERIFIED PRIOR TO THE COMMENCEMENT OF ANY WORK.
- CONTRACTOR SHALL VERIFY EXISTING PLUMBING IS ADEQUATE FOR NEW LAYOUT AND MODIFY PIPING SHOWN ON THIS PLAN AS REQUIRED TO PROVIDE A PROPERLY WORKING SYSTEM.

CLOUDDED AREAS DENOTE "RECORD DOCUMENTS" INFORMATION OBTAINED FROM AS-BUILT DRAWINGS SUPPLIED BY THE GENERAL CONTRACTOR. THE ARCHITECT IS IN NO WAY RESPONSIBLE FOR ACCURACY OF RECORD INFORMATION CONTAINED HEREIN.

GAMBELSKY BENTON ARCHITECTS P.C.
622 Tijeras Avenue NW
Albuquerque, NM 87102
TP: (505) 842-8865 FAX (505) 842-1693

FILE

CITY OF ALBUQUERQUE
PARKS AND GENERAL SERVICES
DESIGN & DEVELOPMENT DIVISION

TITLE: **BARELAS COMMUNITY CENTER**
FLOOR PLAN - PLUMBING

Design Review Committee
APPROVED
JUN 5 1996
DESIGN REVIEW COMMITTEE


City Engineer Approval

MO/DAY/YR
04/19/96

City Project No. **4877.91**

Zone Map No.

Sheet **M-B** 5 of 51

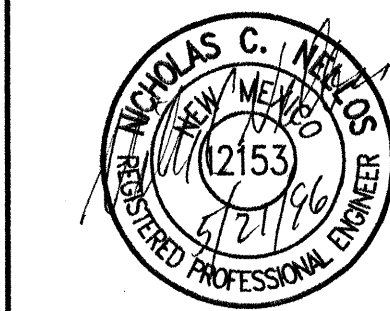

REVISIONS/REMARKS		BY
AS BUILT INFORMATION		DPL
NO. DATE		
1 8/31/99		
DESIGNED BY:		DATE:
DRAWN BY: MMS		DATE:
CHECKED BY: NCN		DATE:


SURVEY INFORMATION		BENCH MARK		AS BUILT INFORMATION	
FIELD NOTES					
NO.	BY	DATE	CONTRACTOR	DATE:	DATE:
			WORK STAKED BY	DATE:	DATE:
			INSPECTOR'S APPROVAL	DATE:	DATE:
			FIELD VERIFICATION BY	DATE:	DATE:
			DRAWING CORRECTED BY	DATE:	DATE:
			MICRO—FILM INFORMATION		
			RECORDED BY	DATE:	DATE:
			NO.		

MECHANICAL EQUIPMENT SCHEDULE

MARK	FUNCTION	SERVES	LOCATION	OPERATING CONDITIONS	CAPACITIES & MOTOR RATINGS	MANUFACTURER & MODEL	REMARKS
EF	EXHAUST FAN	TOILET ROOMS	Roof	5300 Ft. elev.	300 CFM @ 0.25" S.P. 959 fan RPM, 2809 FPM tip speed 1/4 HP, 115V, 1 Ph, 60Hz	GREENHECK: GB-80-4	Provide w/prefab roof curb, backdraft damper, and disconnect on unit.
G-1	GRILLE	EXHAUST SYSTEM	Gypboard ceiling	-----	See plan for throat size and CFM. 12" x 12" panel face	KRUEGER: 6590-0BD	Off-white finish. Provide with opposed blade damper.
G-2	GRILLE	EXHAUST SYSTEM	Interior sidewall	-----	See plan for throat size and CFM	KRUEGER: S580H-0BD	Off-white finish. Provide with opposed blade damper.
R-1	REGISTER	SUPPLY AIR	Interior sidewall	-----	See plan for throat size	KRUEGER: 580V-0BD	Off-white finish. Provide with opposed blade damper.

MECHANICAL SYMBOLS

	CLEANOUT
	DOUBLE CLEANOUT
	RETURN AIR GRILLE
	RECTANGULAR DUCT -- INSIDE DIMENSIONS, FIRST FIGURE IS SIDE SHOWN
	TURNING VANES
	TANK TYPE WATER CLOSET
	URINAL
	WALL MOUNTED LAVATORY
	POINT OF NEW CONNECTION
	SANITARY SEWER
	VENT PIPING
	COLD WATER
	HOT WATER
	BALL VALVE

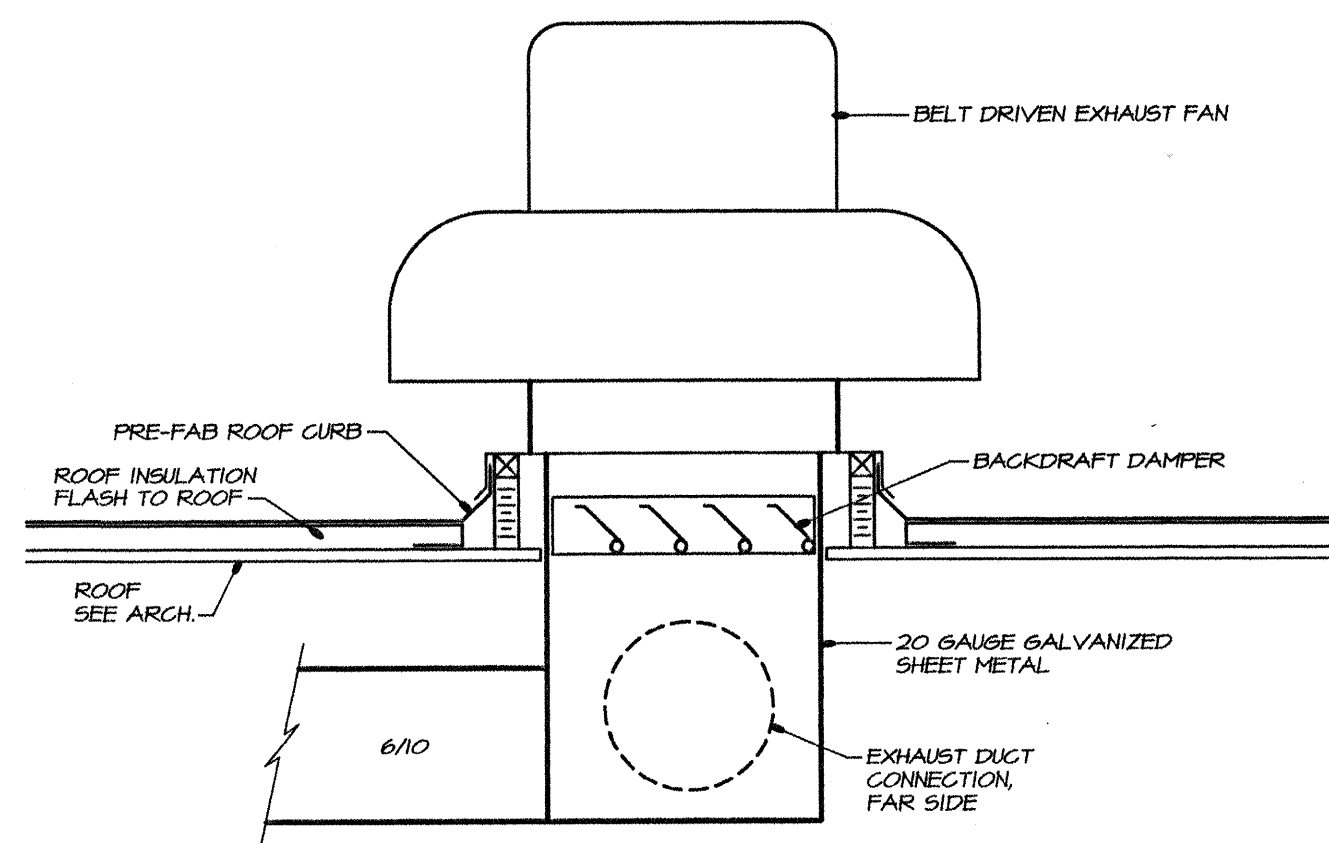


EXHAUST FAN DETAIL

NO SCALE


1
M2-B

PER ADDENDUM #2
Sheet M2-B: Detail #1: cutback existing built-up roofing and reflash per NRCA and roofing manufacturer's recommendations. See General Notes, Sheet A4-DC, and Specifications.

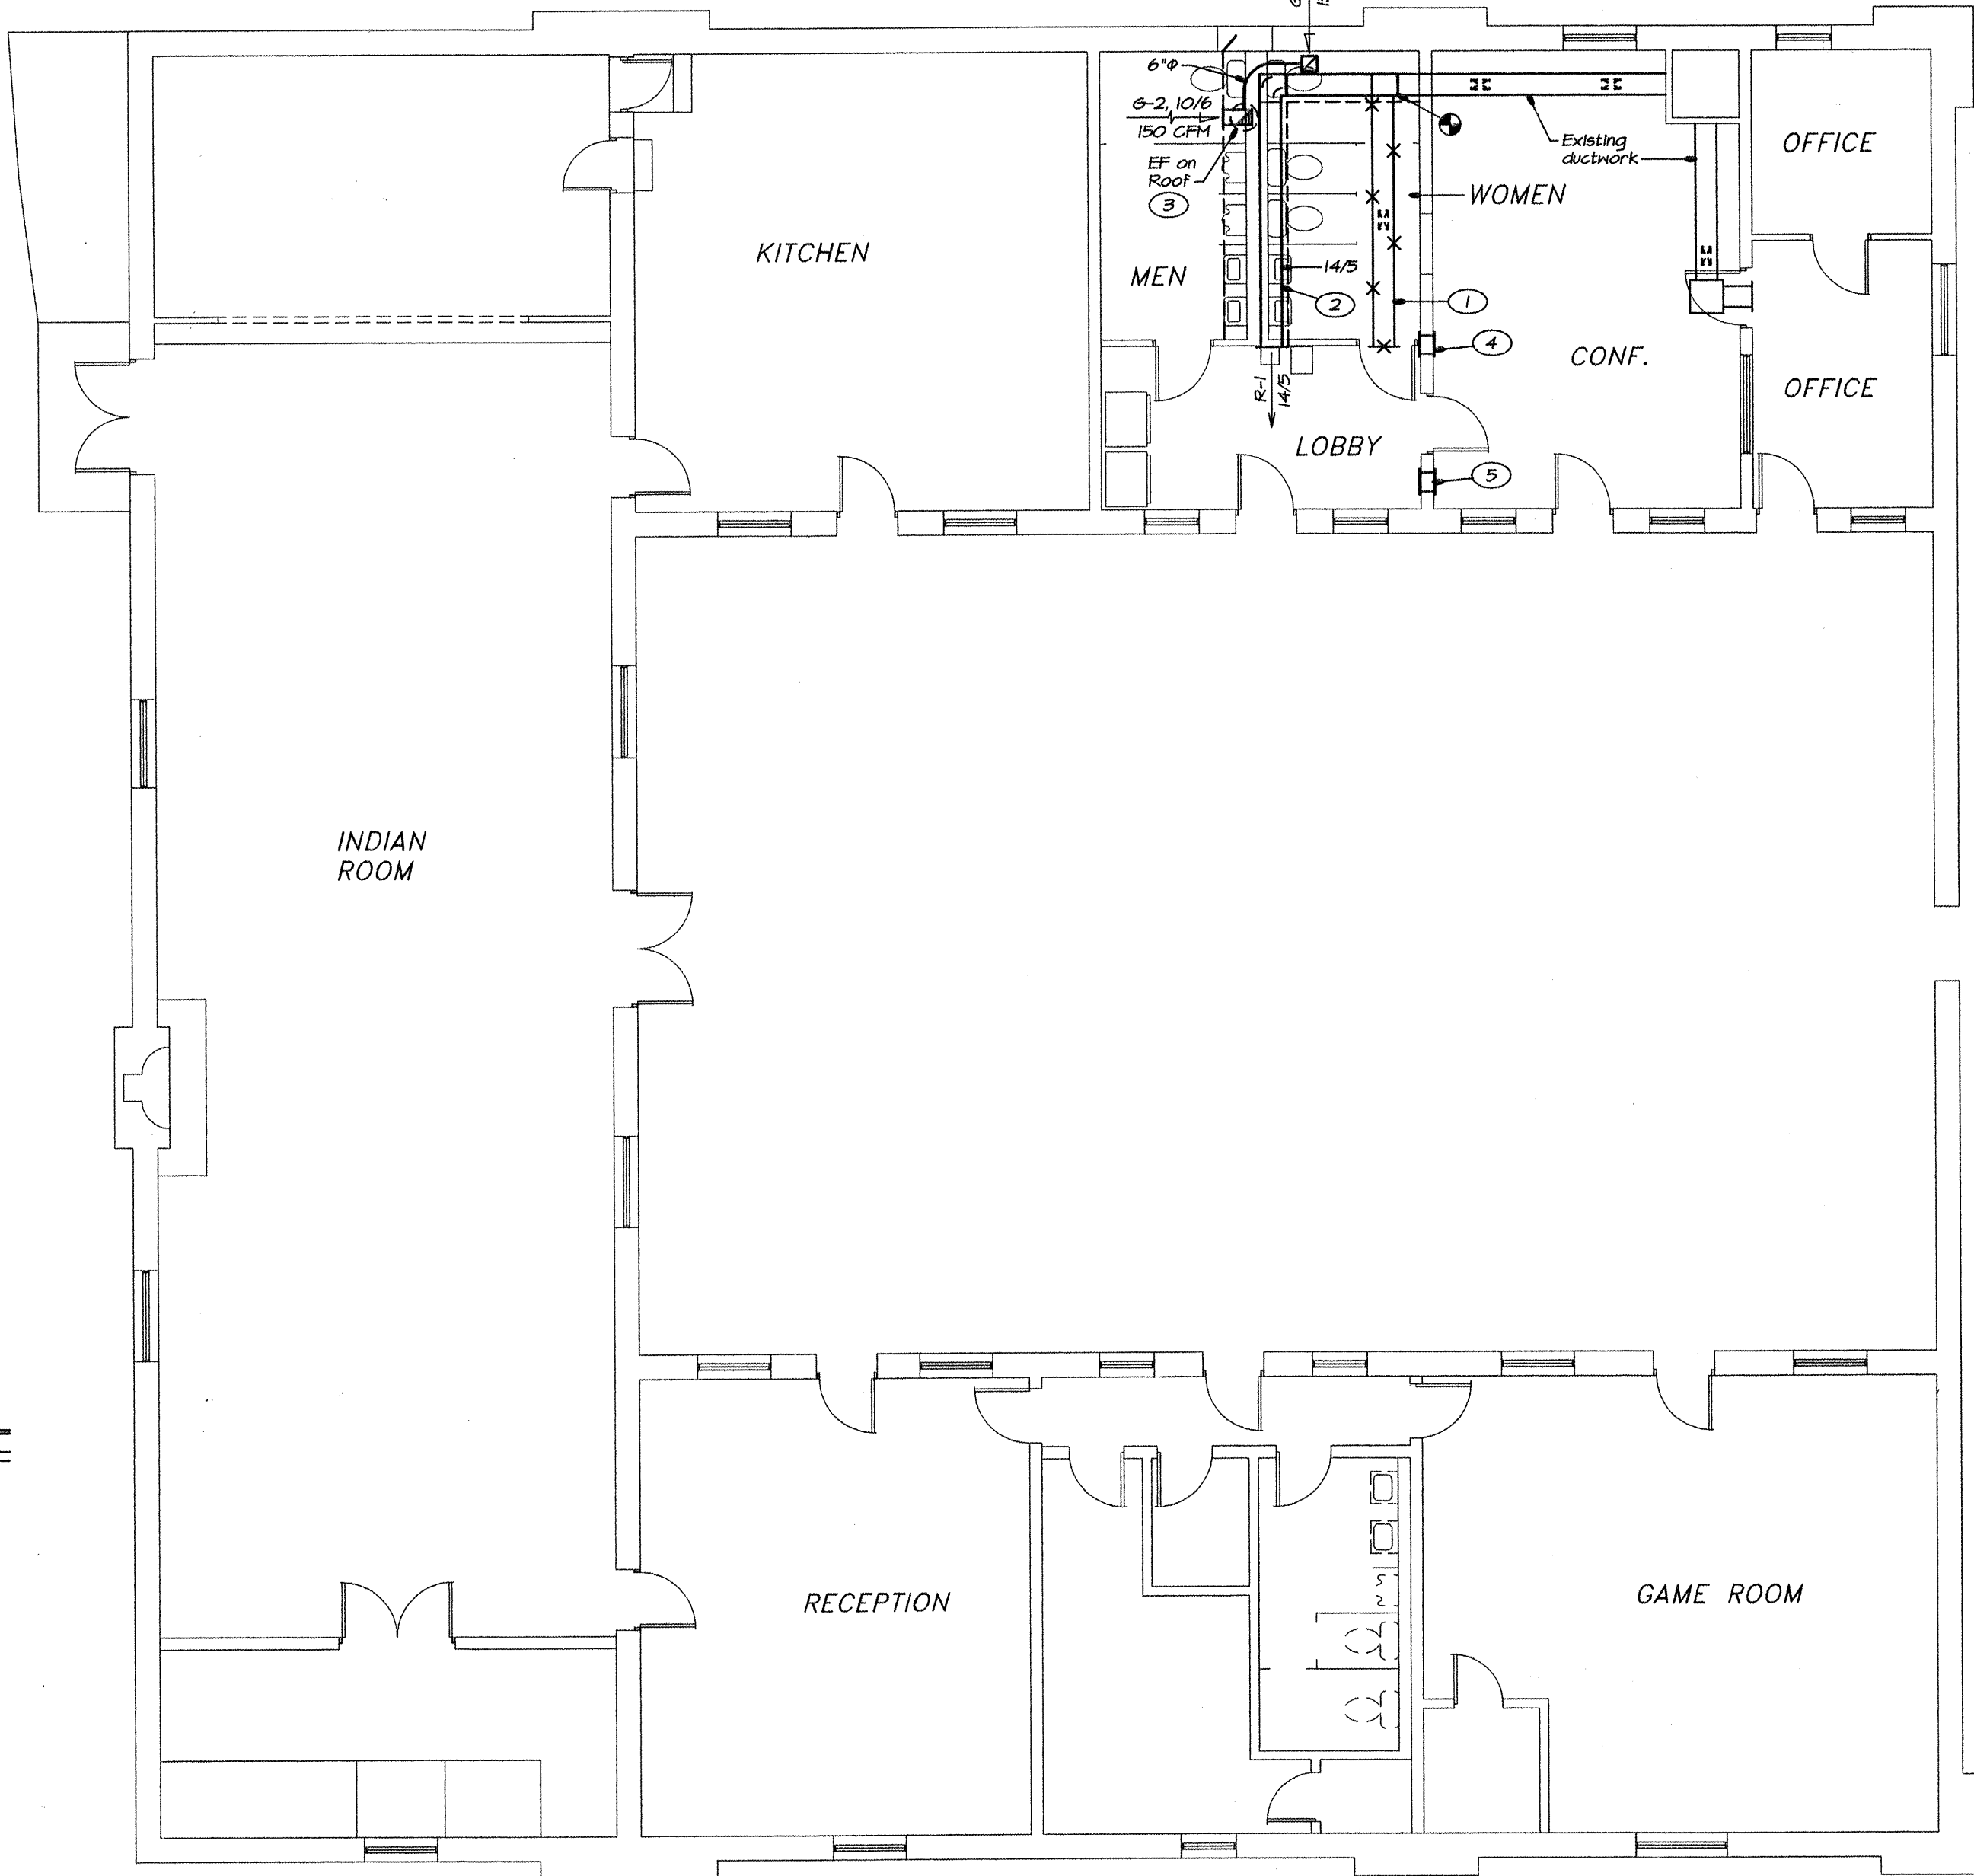

FLOOR PLAN - HVAC

SCALE: 1/8" = 1'-0"

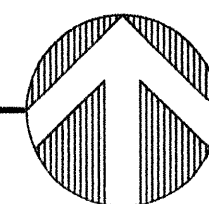

KEYED NOTES

- DUCTWORK AND REGISTERS MARKED WITH "X's" SHALL BE REMOVED.
- INSTALL NEW DUCTWORK AS SHOWN IN FURRED DOWN AREA.
- INSTALL EXHAUST FAN ON ROOF PER DETAIL 1/M2-B.
- EXISTING GRILLES IN WALL SHALL BE REMOVED AND REINSTALLED SOUTH OF DOOR BETWEEN LOBBY AND CONF. SEAL WALL AND FINISH TO MATCH EXISTING. FIELD VERIFY SIZE.
- INSTALL REUSED GRILLES ON WALL AND DUCT SLEEVE SIZED TO MATCH GRILLE SIZE THRU WALL. BOTTOM AT 6" A.F.F.

GENERAL NOTES

- ALL JOINTS AND SEAMS ON SUPPLY, RETURN, AND EXHAUST AIR DUCTS SHALL BE SEALED AIRTIGHT WITH AN APPROVED HEAVY MASTIC DUCT SEALANT. DUCT TAPE IS NOT ACCEPTABLE.


CLOUDED AREAS DENOTE "RECORD DOCUMENTS" INFORMATION OBTAINED FROM AS-BUILT DRAWINGS SUPPLIED BY THE GENERAL CONTRACTOR. THE ARCHITECT IS IN NO WAY RESPONSIBLE FOR ACCURACY OF RECORD INFORMATION CONTAINED HEREIN.

GAMELSKY BENTON ARCHITECTS P.C.
622 Tijeras Avenue NW
Albuquerque, NM 87102
TEL (505) 842-8865 FAX (505) 842-1693

FILE

CITY OF ALBUQUERQUE
PARKS AND GENERAL SERVICES
DESIGN & DEVELOPMENT DIVISION

TITLE: BARELAS COMMUNITY CENTER
FLOOR PLAN - HVAC

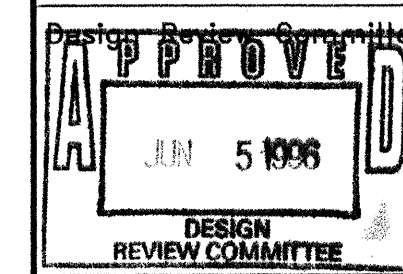

City Engineer Approval

Last Design Update

MO/DAY/YR

04/19/96

MO/DAY/YR

City Project No.

4877.91

Zone Map No.

Sheet

M2-B

6 Of 31

AS BUILT INFORMATION

CONTRACTOR

DATE:

WORK STATED BY

DATE:

INSPECTOR'S APPROVAL

DATE:

FIELD VERIFICATION BY

DATE:

BENCH MARK

DATE:

NO.

DATE:

NO.

DATE:

NO.

DATE:

SURVEY INFORMATION

FIELD NOTES

NO.

DATE:

NO.

DATE:

NO.

DATE:

BY

DPL

REVISIONS/REMARKS

AS BUILT INFORMATION

NO.

DATE:

NO.

DATE:

NO.

DATE:

NO.

DATE:

NO.

DATE:

NO.

DATE:

DESIGNED BY:

MMS

DRAWN BY:

NON

CHECKED BY:

NON


ELECTRICAL SYMBOLS

④	FLUORESCENT LIGHT FIXTURE NUMBER INDICATES FIXTURE TYPE
②	CEILING LIGHT FIXTURE. NUMBER INDICATES FIXTURE TYPE
⑦H	BRACKET LIGHT FIXTURE. NUMBER INDICATES FIXTURE TYPE
⊗ ₂	EXIT LIGHT FIXTURE. NUMBER INDICATES FIXTURE TYPE
⌈ ₄	EMERGENCY LIGHT. NUMBER INDICATES FIXTURE TYPE
⊕	DUPLEX RECEPTACLE
GFCI ⊕	GFCI DUPLEX RECEPTACLE
ⓂH	WALL MOUNTED JUNCTION BOX
Ⓜ	JUNCTION BOX CEILING
Ⓜ ₅	MOTOR-HORSEPOWER AS INDICATED
Ⓜ	DISCONNECT SWITCH FUSED UNLESS NOTED OTHERWISE
■	LIGHTING PANEL
■	POWER PANEL
S	SINGLE POLE SWITCH
S ₂	DOUBLE POLE SWITCH
S ₃	3-WAY SWITCH
S ₄	4-WAY SWITCH
S _{TE}	SINGLE POLE MANUAL MOTOR STARTER w/THERMAL ELEMENT
WP	INDICATES WEATHERPROOF
ⓂH	THERMOSTAT
⌈	BRANCH CIRCUIT WITH NEUTRAL, HOT, SWITCH, & GROUND WIRES ARROWHEAD INDICATES HOME RUN NO. OF ARROWS INDICATES NO. OF CIRCUITS

SCHEDULE APPLIES TO BARELAS, DENNIS CHAVEZ, AND MESA VERDE PROJECTS

LIGHTING FIXTURE SCHEDULE


FIXT. NO.	LAMPS TYPE	NO.	VOLTS	FIXTURE MANUFACTURER	CATALOG NO.	MOUNTING	REMARKS
1	F32/T8/41K	2	120	LITHONIA	SP232-A12.125-120-GE8	Recessed in gyp. ceiling	2-lamp flanged troffer with T-8 lamps and electronic ballast.
2	F32/T8/41K	4	120	LITHONIA	2SPG-432-A12.125-120-GE8	Recessed in grid ceiling	4-lamp grid troffer with T-8 lamps and electronic ballast.
3	100 WATT HPS	1	120	LITHONIA	TWH-100S-120-VG-PE	Wall mounted	HPS wall pack with vandal guard and photocell.
4	WITH FIXTURE	1	120	LITHONIA	EL2-WG7	Wall mounted	Emergency light with battery pack.
5	WITH FIXTURE	1	120	LITHONIA	LESW-1R-120/277-ELN	Wall mounted	Exit light.
6	F32/T8/41K	2	120	PRUDENTIAL	P60-D3-M2-2-BW-04-BLW-120-GE8	Pendant	2-lamp pendant up & down light w/T-8 lamps & electronic ballast.
7	75 WATT A-19	1	120	BRYANT	5228	Ceiling surface	Porcelain keyless lamp holder.
8	F32/T8/41K	2	120	LITHONIA	WS232-A12125-120-GE8	Wall mounted	2-lamp wall bracket w/T8 lamps and electronic ballast.
9	F32/T8/41K	2	120	LITHONIA	M232-A12125-120-GE8	Pendant	2-lamp pendant modular w/T8 lamps and electronic ballast.

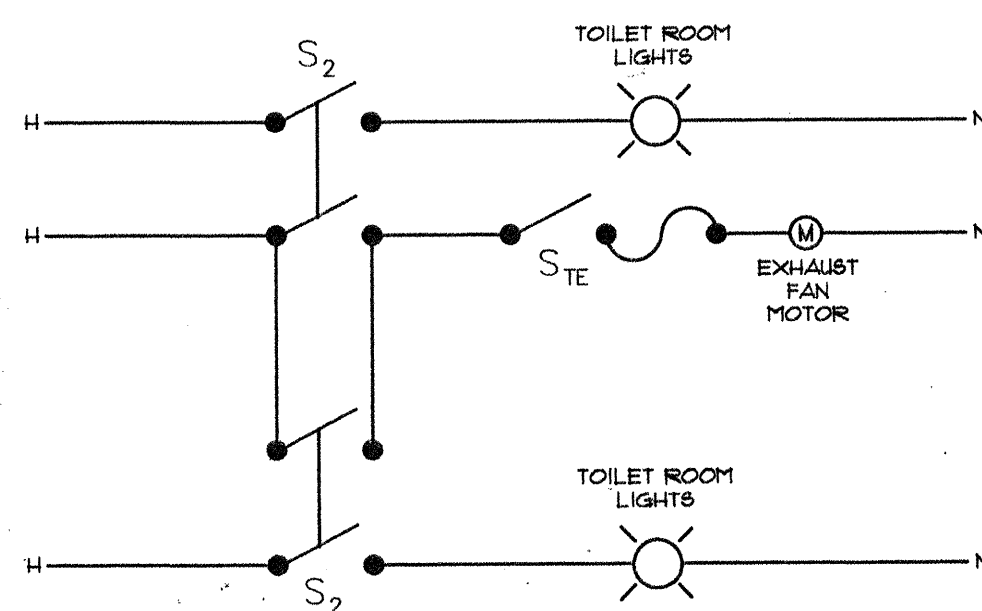

TOILET ROOM EXHAUST FAN CONTROL DIAGRAM

NO SCALE

1
E1-B

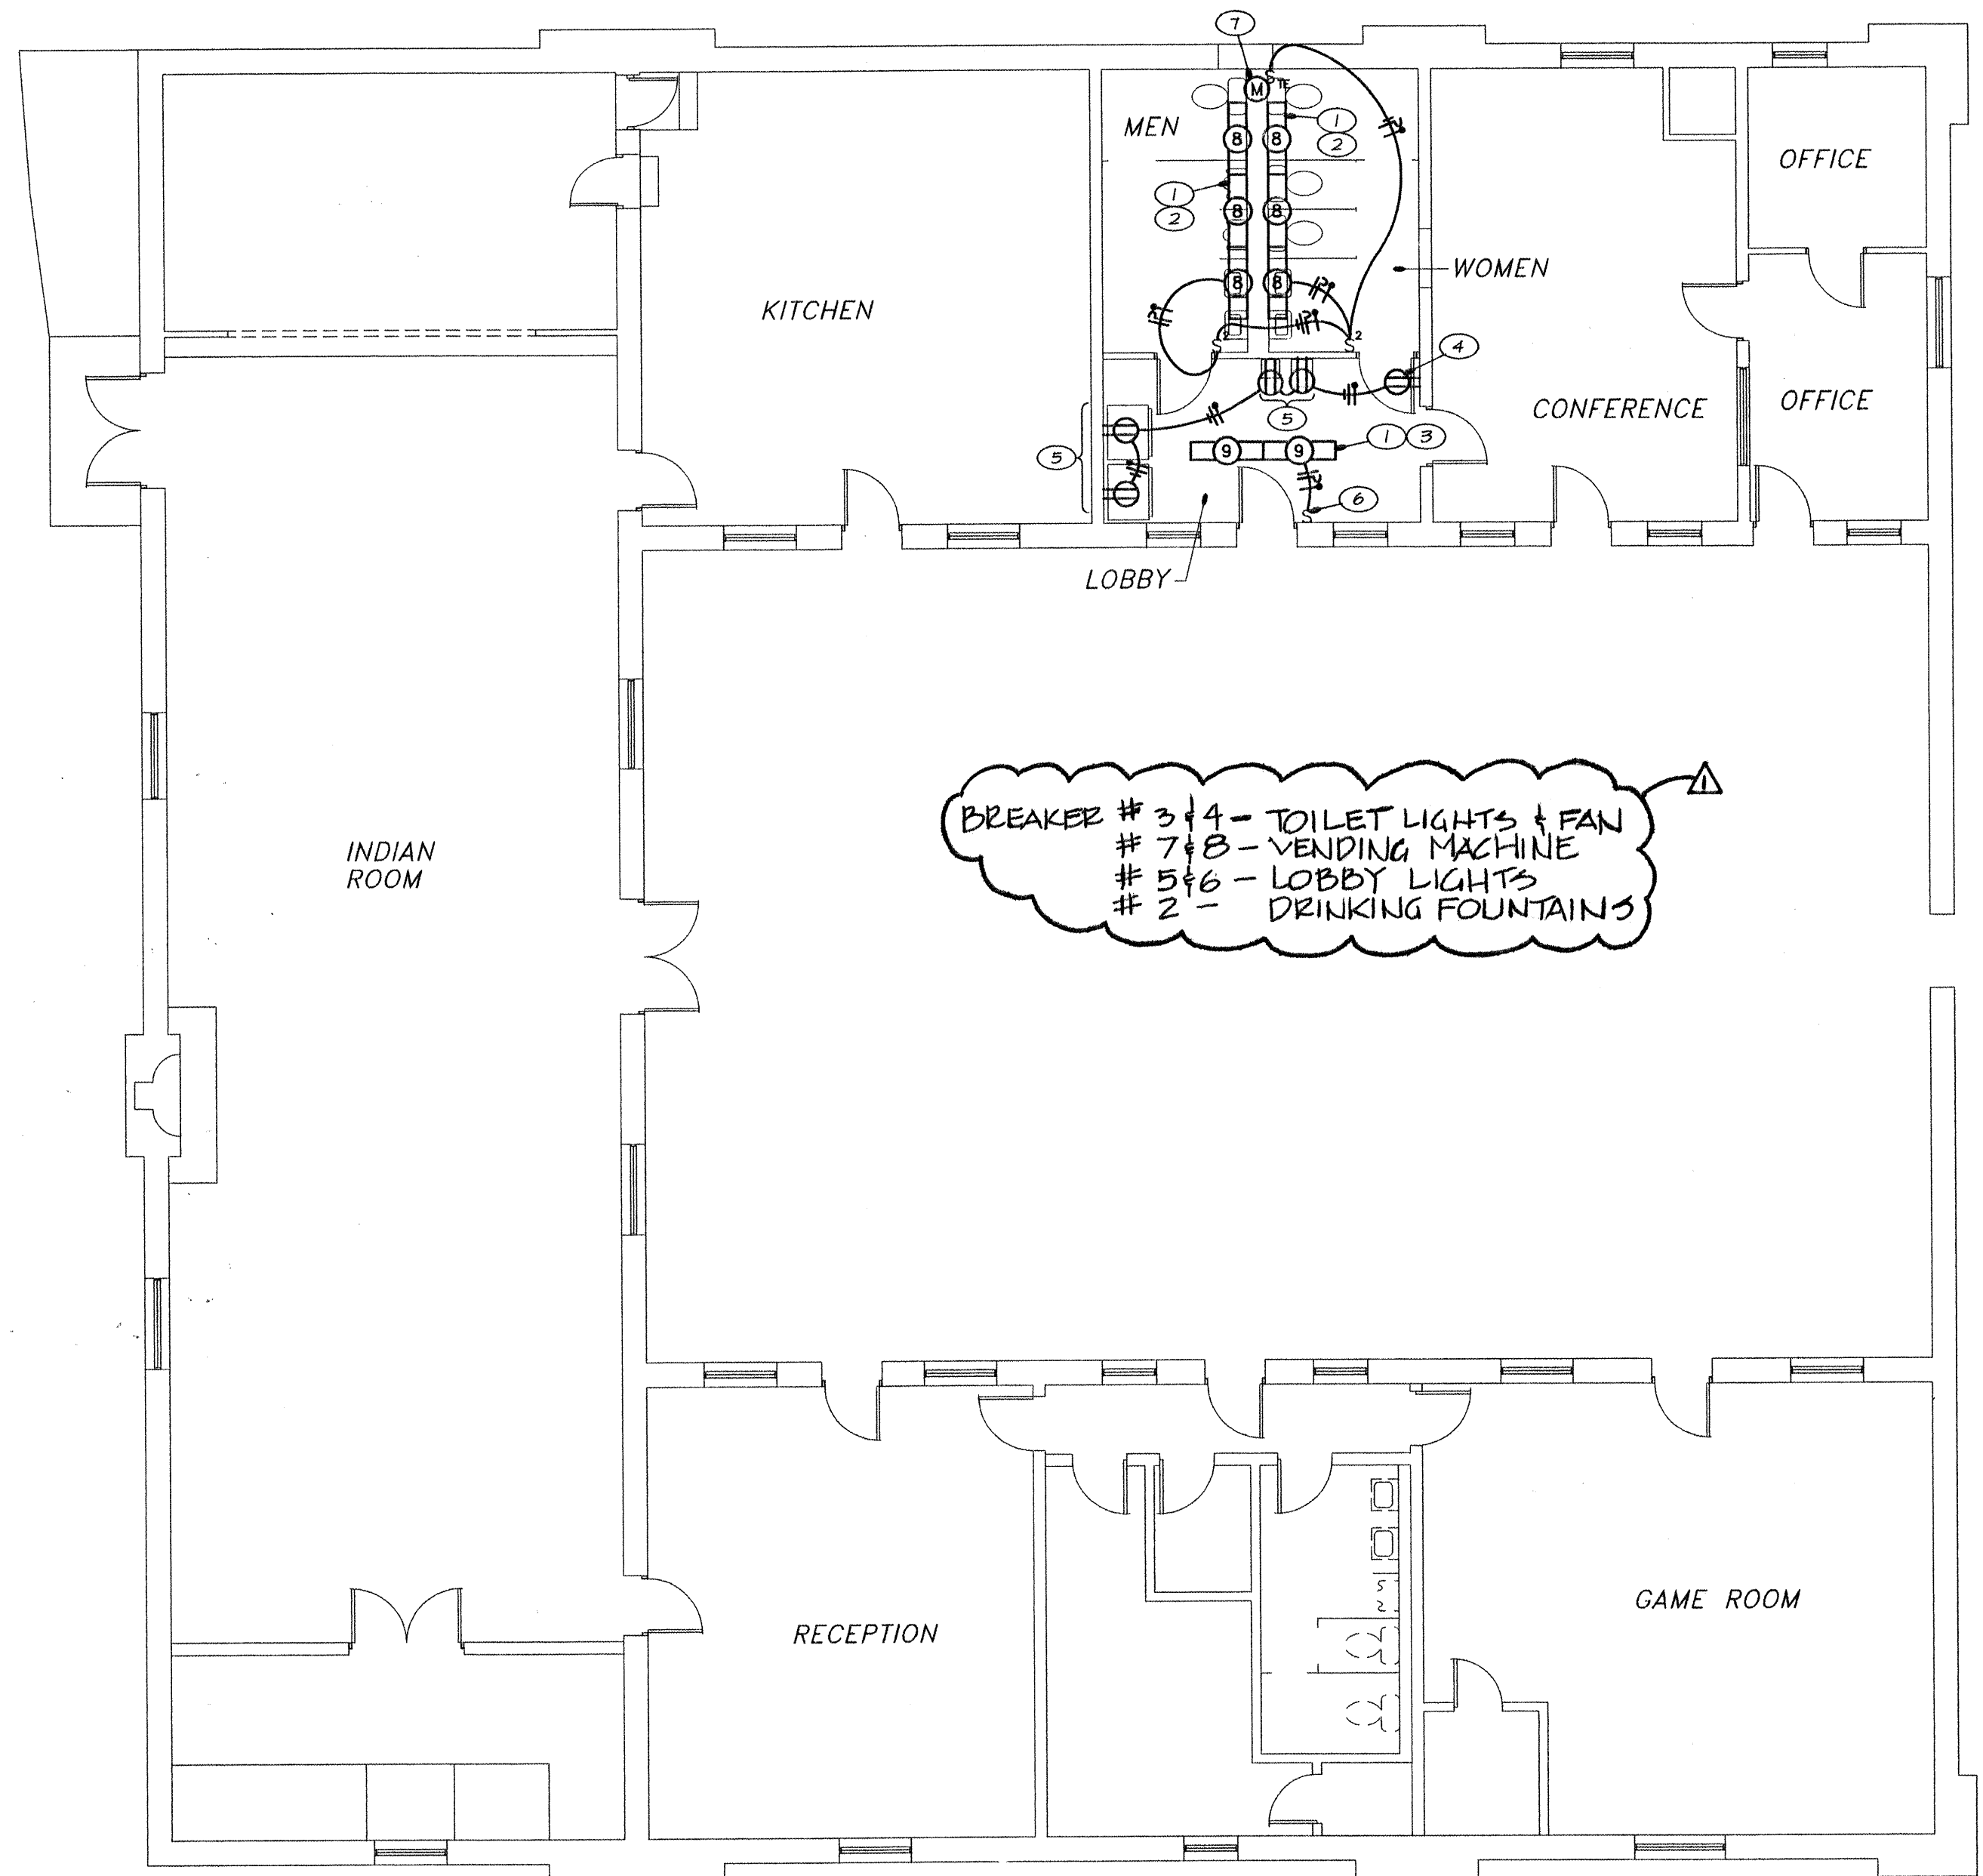

FLOOR PLAN - LIGHTING

SCALE: 1/8" = 1'-0"

KEYED NOTES

- REMOVE EXISTING LIGHTING FIXTURES IN THIS ROOM AND INSTALL NEW LIGHTING FIXTURES AND SWITCHES AS SHOWN. RECONNECT TO EXISTING CIRCUITS. MINIMIZE EXPOSED EMT; WHERE EXPOSED INSTALL NEATLY.
- WALL MOUNT LIGHTING FIXTURES ABOVE MIRRORS.
- PENDANT LIGHTING FIXTURES MOUNTED WITH TOP 4" BELOW BOTTOM OF VIGAS.
- REPLACE EXISTING RECEPTACLE.
- INSTALL NEW RECEPTACLES AND CONNECT TO EXISTING CIRCUIT.
- REPLACE EXISTING SWITCH WITH NEW SWITCH. REMOVE SURFACE MOUNTED J-BOX, RECEPTACLE AND WIREMOLD ON THIS WALL.
- EXHAUST FAN ON ROOF. WIRE TO RUN WHENEVER LIGHTS IN EITHER TOILET ROOM ARE ON, SEE DETAIL 1/E1-B.

CLOUDED AREAS DENOTE "RECORD DOCUMENTS" INFORMATION OBTAINED FROM AS-BUILT DRAWINGS SUPPLIED BY THE GENERAL CONTRACTOR. THE ARCHITECT IS IN NO WAY RESPONSIBLE FOR ACCURACY OF RECORD INFORMATION CONTAINED HEREIN.

GAMELSKY BENTON ARCHITECTS P.C.
622 Tijeras Avenue NW
Albuquerque, NM 87102
TEL (505) 842-8865 FAX (505) 842-1893

FILE

CITY OF ALBUQUERQUE
PARKS AND GENERAL SERVICES
DESIGN & DEVELOPMENT DIVISION

TITLE: BARELAS COMMUNITY CENTER FLOOR PLAN - LIGHTING & POWER

Design Review Committee
APPROVED
5/19/96
DESIGN REVIEW COMMITTEE

City Engineer Approval

Last Design Update

MO/DAY/YR
04/19/96
MO/DAY/YR

City Project No.

4877.91

Zone Map No.

Sheet

E1-B

7 of 31



SURVEY INFORMATION

FIELD NOTES

NO. BY DATE

BENCH MARK

AS BUILT INFORMATION

CONTRACTOR

DATE: WORK STARTED BY

DATE: INSPECTOR'S APPROVAL

DATE: FIELD VERIFICATION BY

DATE: DRAWING CORRECTED BY

DATE: MICRO-FILM INFORMATION

DATE: RECORDED BY

NO.