
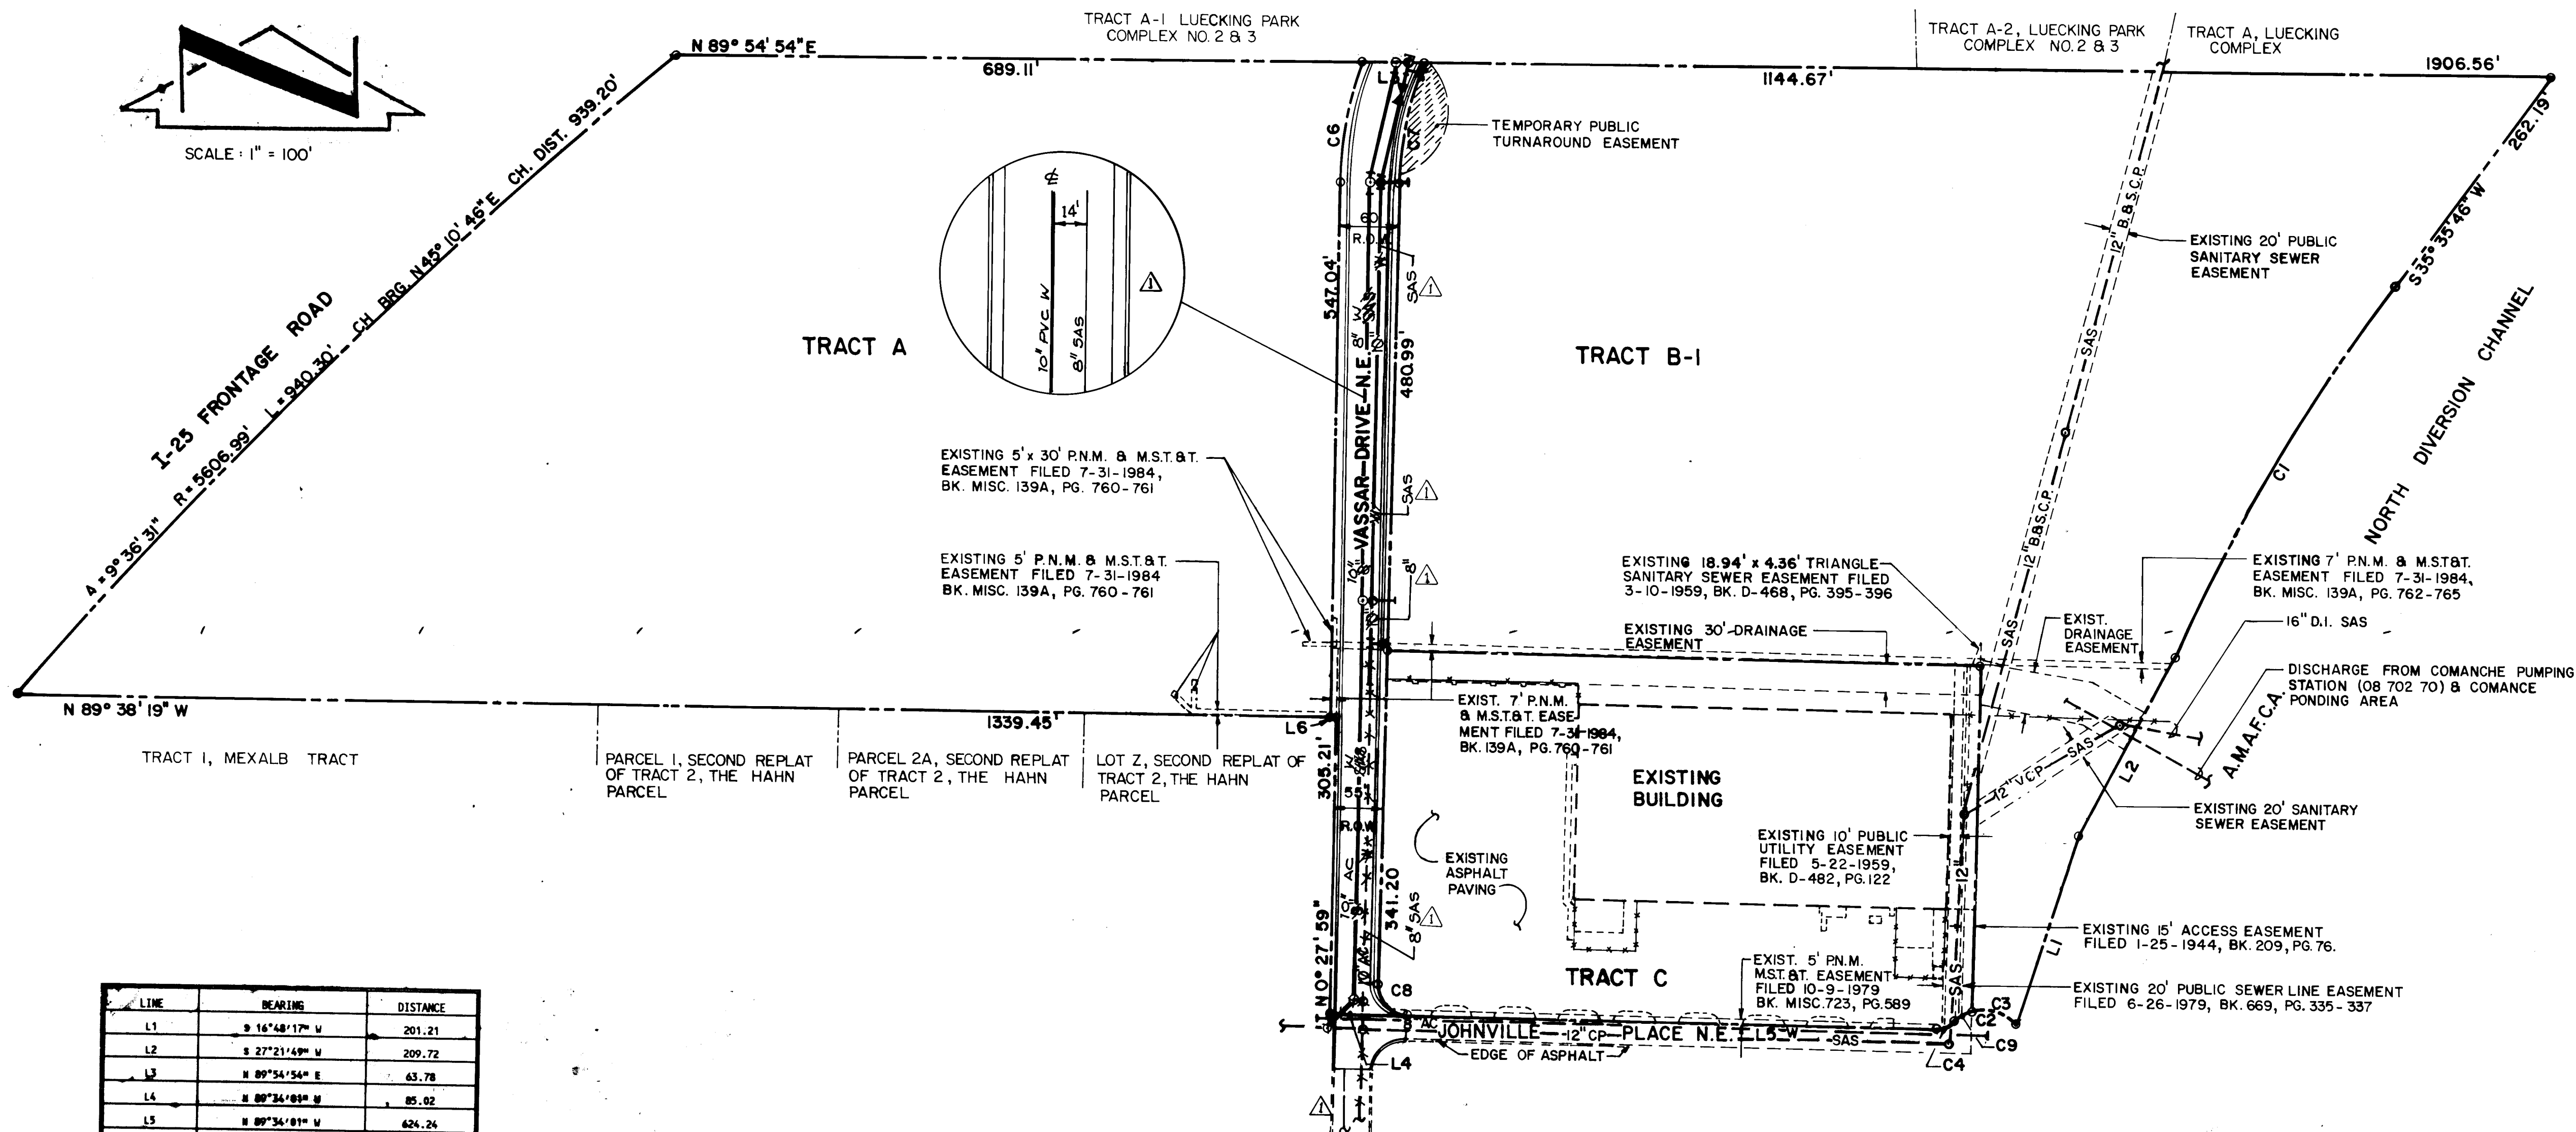


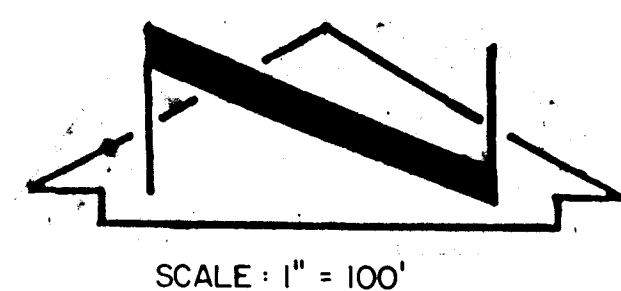

LINE	BEARING	DISTANCE
L1	S 16°48'17" W	201.21
L2	S 27°21'49" W	209.72
L3	N 89°54'54" E	63.78
L4	N 89°54'09" E	85.02
L5	N 89°54'01" E	624.24
L6	N 89°58'19" W	5.00

CURVE	ARC	DELTA	RADIUS	CHORD LENGTH	CHORD BEARING	TAN LENGTH
C1	443.65	12°09'47"	2089.86	442.81	S 29°31'38" W	222.66
C2	70.68	89°59'31"	45.00	63.64	N 88°59'11" W	44.99
C3	49.47	62°58'52"	45.00	47.01	N 75°28'51" W	27.57
C4	19.38	44°24'55"	25.00	18.90	S 68°13'31" W	10.21
C5	-----	-----	-----	-----	-----	-----
C6	126.66	17°42'00"	410.00	126.16	N 09°18'59" E	63.84
C7	128.11	20°58'19"	350.00	127.40	S 10°57'08" W	64.78
C8	47.14	90°02'00"	30.00	42.44	S 44°33'01" E	30.02
C9	21.21	27°00'39"	45.00	21.02	S 59°31'23" W	10.81

RECORD DRAWING

STAMPED BY
BY LASON

26 5002.90 0895

900055

ENGINEER'S SEAL			AS BUILT INFORMATION		
RECORD DRAWING			BENCH MARKS		
I, Jeffrey G. Mortensen, Registered Professional Engineer in the State of New Mexico, do hereby certify that this "as-built" information was obtained by me or under my supervision and represents the "as-built" conditions of this project, and is true and correct to the best of my knowledge and belief. All vertical and horizontal dimensions should be field verified prior to use on future projects.			THE STATION IS A STANDARD NMHC BRASS TABLET, STAMPED "STA M-6", SET IN TOP OF A CONCRETE POST FLUSH W/ THE GROUND. TO REACH THE STATION FROM THE INTERSECTION OF MONTGOMERY BLVD. & CARLISLE BLVD., N.E. GO WEST ON MONTGOMERY BLVD. 0.1 MILES TO THE CHANNEL & THE STATION. THE STATION IS LOCATED AT THE EAST END OF THE BRIDGE CROSSING THE NORTH DIVERSION CHANNEL. ELEVATION = 510.49' (M.S.L.D.)		
DATE 07/94			DATE 03/95		
DESIGNED BY JGM			WORKED BY J.M.A.		
DRAWN BY MSC			INSPECTED BY M.D.S.		
CHECKED BY JGM			DATE 03/95		
NO. DATE			NO. DATE		
REVISIONS			REVISIONS		
DESIGN			DESIGN		
CITY OF ALBUQUERQUE PUBLIC WORKS DEPARTMENT ENGINEERING GROUP			CITY OF ALBUQUERQUE PUBLIC WORKS DEPARTMENT ENGINEERING GROUP		
TITLE: COMANCHE BUSINESS PARK VASSAR DRIVE EXTENSION WATER & SANITARY SEWER SITE PLAN			TITLE: COMANCHE BUSINESS PARK VASSAR DRIVE EXTENSION WATER & SANITARY SEWER SITE PLAN		
APPROVALS			APPROVALS		
ENGINEER			ENGINEER		
DATE			DATE		
DRG CHAIRMAN			DRG CHAIRMAN		
TRANSPORTATION			TRANSPORTATION		
HYDROLOGY			HYDROLOGY		
PROJECT NO. 5007.90			PROJECT NO. 5007.90		
MAP NO. G16			MAP NO. G16		
SHEET 8 OF 15			SHEET 8 OF 15		