

PUBLIC IMPROVEMENT PLANS
FOR
ROLLING HILLS SUBDIVISION-UNIT THREE
ALBUQUERQUE, NEW MEXICO


MAY 1997

PREPARED FOR:
LONGFORD HOMES OF NEW MEXICO
3200 CARLISLE, NE
ALBUQUERQUE, NM 87110

PREPARED BY:
ISAACSON & ARFMAN, P.A.
128 MONROE ST. NE
ALBUQUERQUE, NM 87108

INDEX TO DRAWINGS

SHEET NO.	TITLE
1	TITLE SHEET
2	SUBDIVISION PLAT
3	GRADING & DRAINAGE PLAN
4	GRADING DETAILS
	<u>PAVING PLAN & PROFILE SHEETS</u>
5	PAVING MASTER PLAN
6	ROLLING ROCK PL. & FOX HILL DR.
7	AUTUMN CANYON RD.
8	WINDSONG PL.
	<u>UTILITY PLAN & PROFILE SHEETS</u>
9	UTILITY MASTER PLAN
10	ROLLING ROCK PL. & FOX HILL DR.
11	AUTUMN CANYON RD.
12	WINDSONG PL.
13	UNSER WATERLINE CONNECTION
14	UNSER WATERLINE CONNECTION & DRAINAGE RUNDOWN

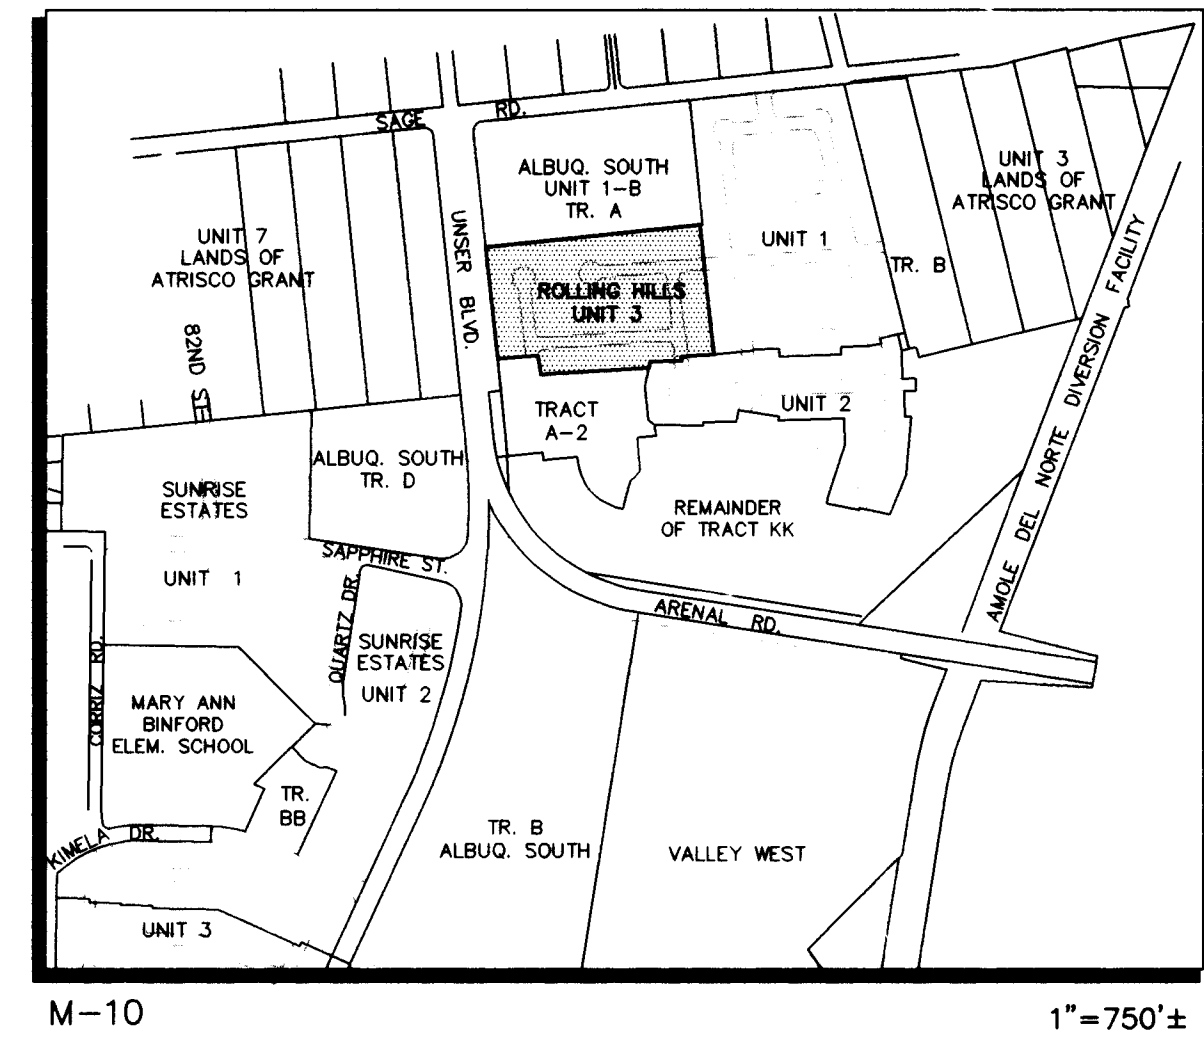


VICINITY MAP

GENERAL NOTES

- All work detailed on these plans to be performed under contract shall, except as otherwise stated or provided for hereon, be constructed in accordance with the City of Albuquerque Standard Specifications for Public Works Construction 1986 Edition as amended with Update No. 6.
- All work on this project shall be performed in accordance with applicable federal, state, and local laws, rules, and regulations concerning construction safety and health.
- Prior to construction, the Contractor shall excavate & verify the horizontal and vertical locations of all obstructions. Should a conflict exist, the Contractor shall notify the Engineer so that the conflict can be resolved with minimum delay.
- Two (2) working days prior to any excavation, Contractor must contact Line Locating Service @ 260-1990 for location of existing utilities.
- Contractor shall conduct his operations in a manner which will minimize interference with local traffic. Contractor shall comply with all applicable laws, ordinances, rules, regulations, and orders of any public body having jurisdiction for the safety of persons or property, and to protect them from damage, injury, or loss. Contractor shall erect and maintain, as required by the conditions and progress of the work, all necessary safeguards for safety continuously and not limited to normal working hours, throughout the duration of the project. Contractor shall adhere to Section 19 of the General Conditions of the City of Albuquerque Standard Specifications for Public Works Construction, 1986, as amended with Update No. 6.
- The Contractor agrees that he shall assume the sole and complete responsibility for the job site conditions during the course of construction of this project, including safety of all persons and property, that this requirement shall apply continuously and not be limited to normal working hours; and that the Contractor shall defend, indemnify, and hold harmless the Owner & Engineer from any and all liability real or alleged, in connection with the performance of work on this project, excepting liability arising from the sole negligence of the Owner or Engineer.
- TRAFFIC CONTROL: Three (3) working days prior to beginning construction the Contractor shall submit to the Construction Coordination Division a detailed construction schedule. Two (2) working days prior to construction, the Contractor shall obtain a barricading permit from the Construction Coordination Division. Contractor shall notify Barricade Engineer (768-2551) prior to occupying an intersection. See Section 19 of the specifications. All street striping altered or destroyed shall be replaced with plastic reflectorized pavement markings by Contractor to location as existing or as shown in this plan set at no additional cost to the Owner.
- When abutting existing pavement to new, sawcut existing pavement to a straight edge and at a right angle, or as approved by the field Engineer. Removal of broken or cracked pavement will also be required.
- Existing curb and gutter not to be removed under the contract which is damaged or displaced by the Contractor shall be removed and replaced by the Contractor at his expense.
- All final backfill for trenches shall be compacted to a minimum 90% maximum density per ASTM D-1557 and as directed by section 701.14.2 and standard drawing number 2315.
- The Contractor shall promptly clean up any material excavated within the public right-of-way or private roadway easements so that the excavated material is not susceptible to being washed down the street or into any public drainage facility.
- Proposed waterline materials shall be either PVC pipe meeting AWWA C900 requirements (6"-12") or ductile iron pipe, thickness class 50 (6"-16").
- All sanitary sewer line stationing refers to sanitary sewer centerline stationing.
- All fittings on waterlines shall have restrained joints as noted on the plans.
- Contractor shall support all existing, underground utility lines which become exposed during construction. Payment for supporting work shall be incidental to waterline and/or sewerline costs.
- Contractor shall assist the Engineer/Inspector in the recording of data on all utility lines and accessories as required by the City of Albuquerque for the preparation of record drawings. Contractor shall not cover utility lines and accessories until all data has been recorded.
- The Contractor is responsible for protecting and maintaining all existing monumentation controls. In the event of inadvertent destruction or alteration, the Contractor must immediately notify the City Chief Surveyor.
- PNM will provide at no cost to the City or the Contractor the required personnel for inspection or observation deemed necessary by PNM while the Contractor is exposing PNM's cables. However, the Contractor shall be charged the total cost associated with repairs to any damaged cables or for any cost associated with supporting or relocating the poles and cables during construction.
- WARNING--EXISTING UTILITY LINE LOCATIONS are shown in an approximate manner only, and such lines may exist where none are shown. The location of any such existing lines is based upon information provided by the utility company, the Owner, or by others, and the information may be incomplete or may be obsolete by the time construction commences.


The Engineer has undertaken no field verification of the location, depth, size, or type of existing underground utility lines, makes no representation pertaining thereto, and assumes no responsibility or liability therefor. The Contractor shall inform itself of the location of any utility line in or near the area of the work in advance of and during excavation work. The Contractor is fully responsible for any and all damage caused by its failure to locate, identify, and preserve any and all existing utilities. The Contractor shall comply with State statutes, municipal and local ordinances, rules and regulations pertaining to the location of these lines and facilities, in planning and conducting excavation, whether by calling or notifying the utilities, complying with "Blue Stakes" procedures, or otherwise.
- Any work occurring within an arterial roadway requires 24 hr. construction.

1 2 3 4 5 6 7 8 9 10 11 12 13 14 15
26 5379.92 984110

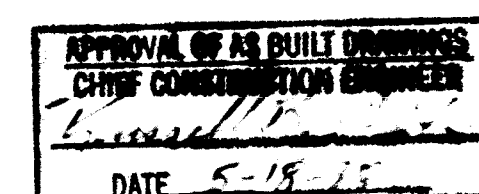


SCANNED BY
RY LASON

DRB NO. 96-290

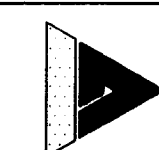

ISAACSON & ARFMAN, P.A.
Consulting Engineering Associates
128 Monroe Street N.E.
New Mexico
917CVR3.DWG 05/05/97

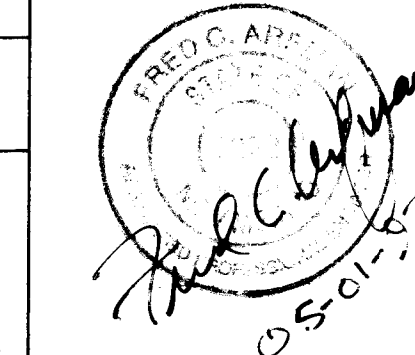


REV.	SHEETS	CITY ENGINEER	DATE	USER	DEPARTMENT	DATE	USER	DEPARTMENT	DATE
ENGINEERS STAMP & SIGNATURE		APPROVALS		ENGINEER		DATE	*****		
		DRC Chairman	6-4-97	APPROVED FOR CONSTRUCTION					
		Transportation	5-16-97						
		Water/Wastewater	5-16-97						
		Hydrology	5-16-97						
		CIP	5-16-97						
Constr. Mngmt.		David Cates/JP	6/4/97	City Engineer Date					
City Project No.		5379.92		Sheet		1		Of 14	

SURVEYOR'S CERTIFICATION


"I, Timothy Aldrich, a duly qualified Registered Professional Land Surveyor under the laws of the State of New Mexico, do hereby certify that the 'as-built' information shown on these drawings was obtained from field construction and 'as-built' surveys performed by me or under my supervision, that the 'as-built' information shown on these drawings was added by me or under my supervision, and that this 'as-built' information is true and correct to the best of my knowledge and belief." Aldrich Land Surveying is not responsible for any of the design concepts, calculations, engineering or intent of the record drawings.

Timothy Aldrich, P.S. No. 7719

04-06-98

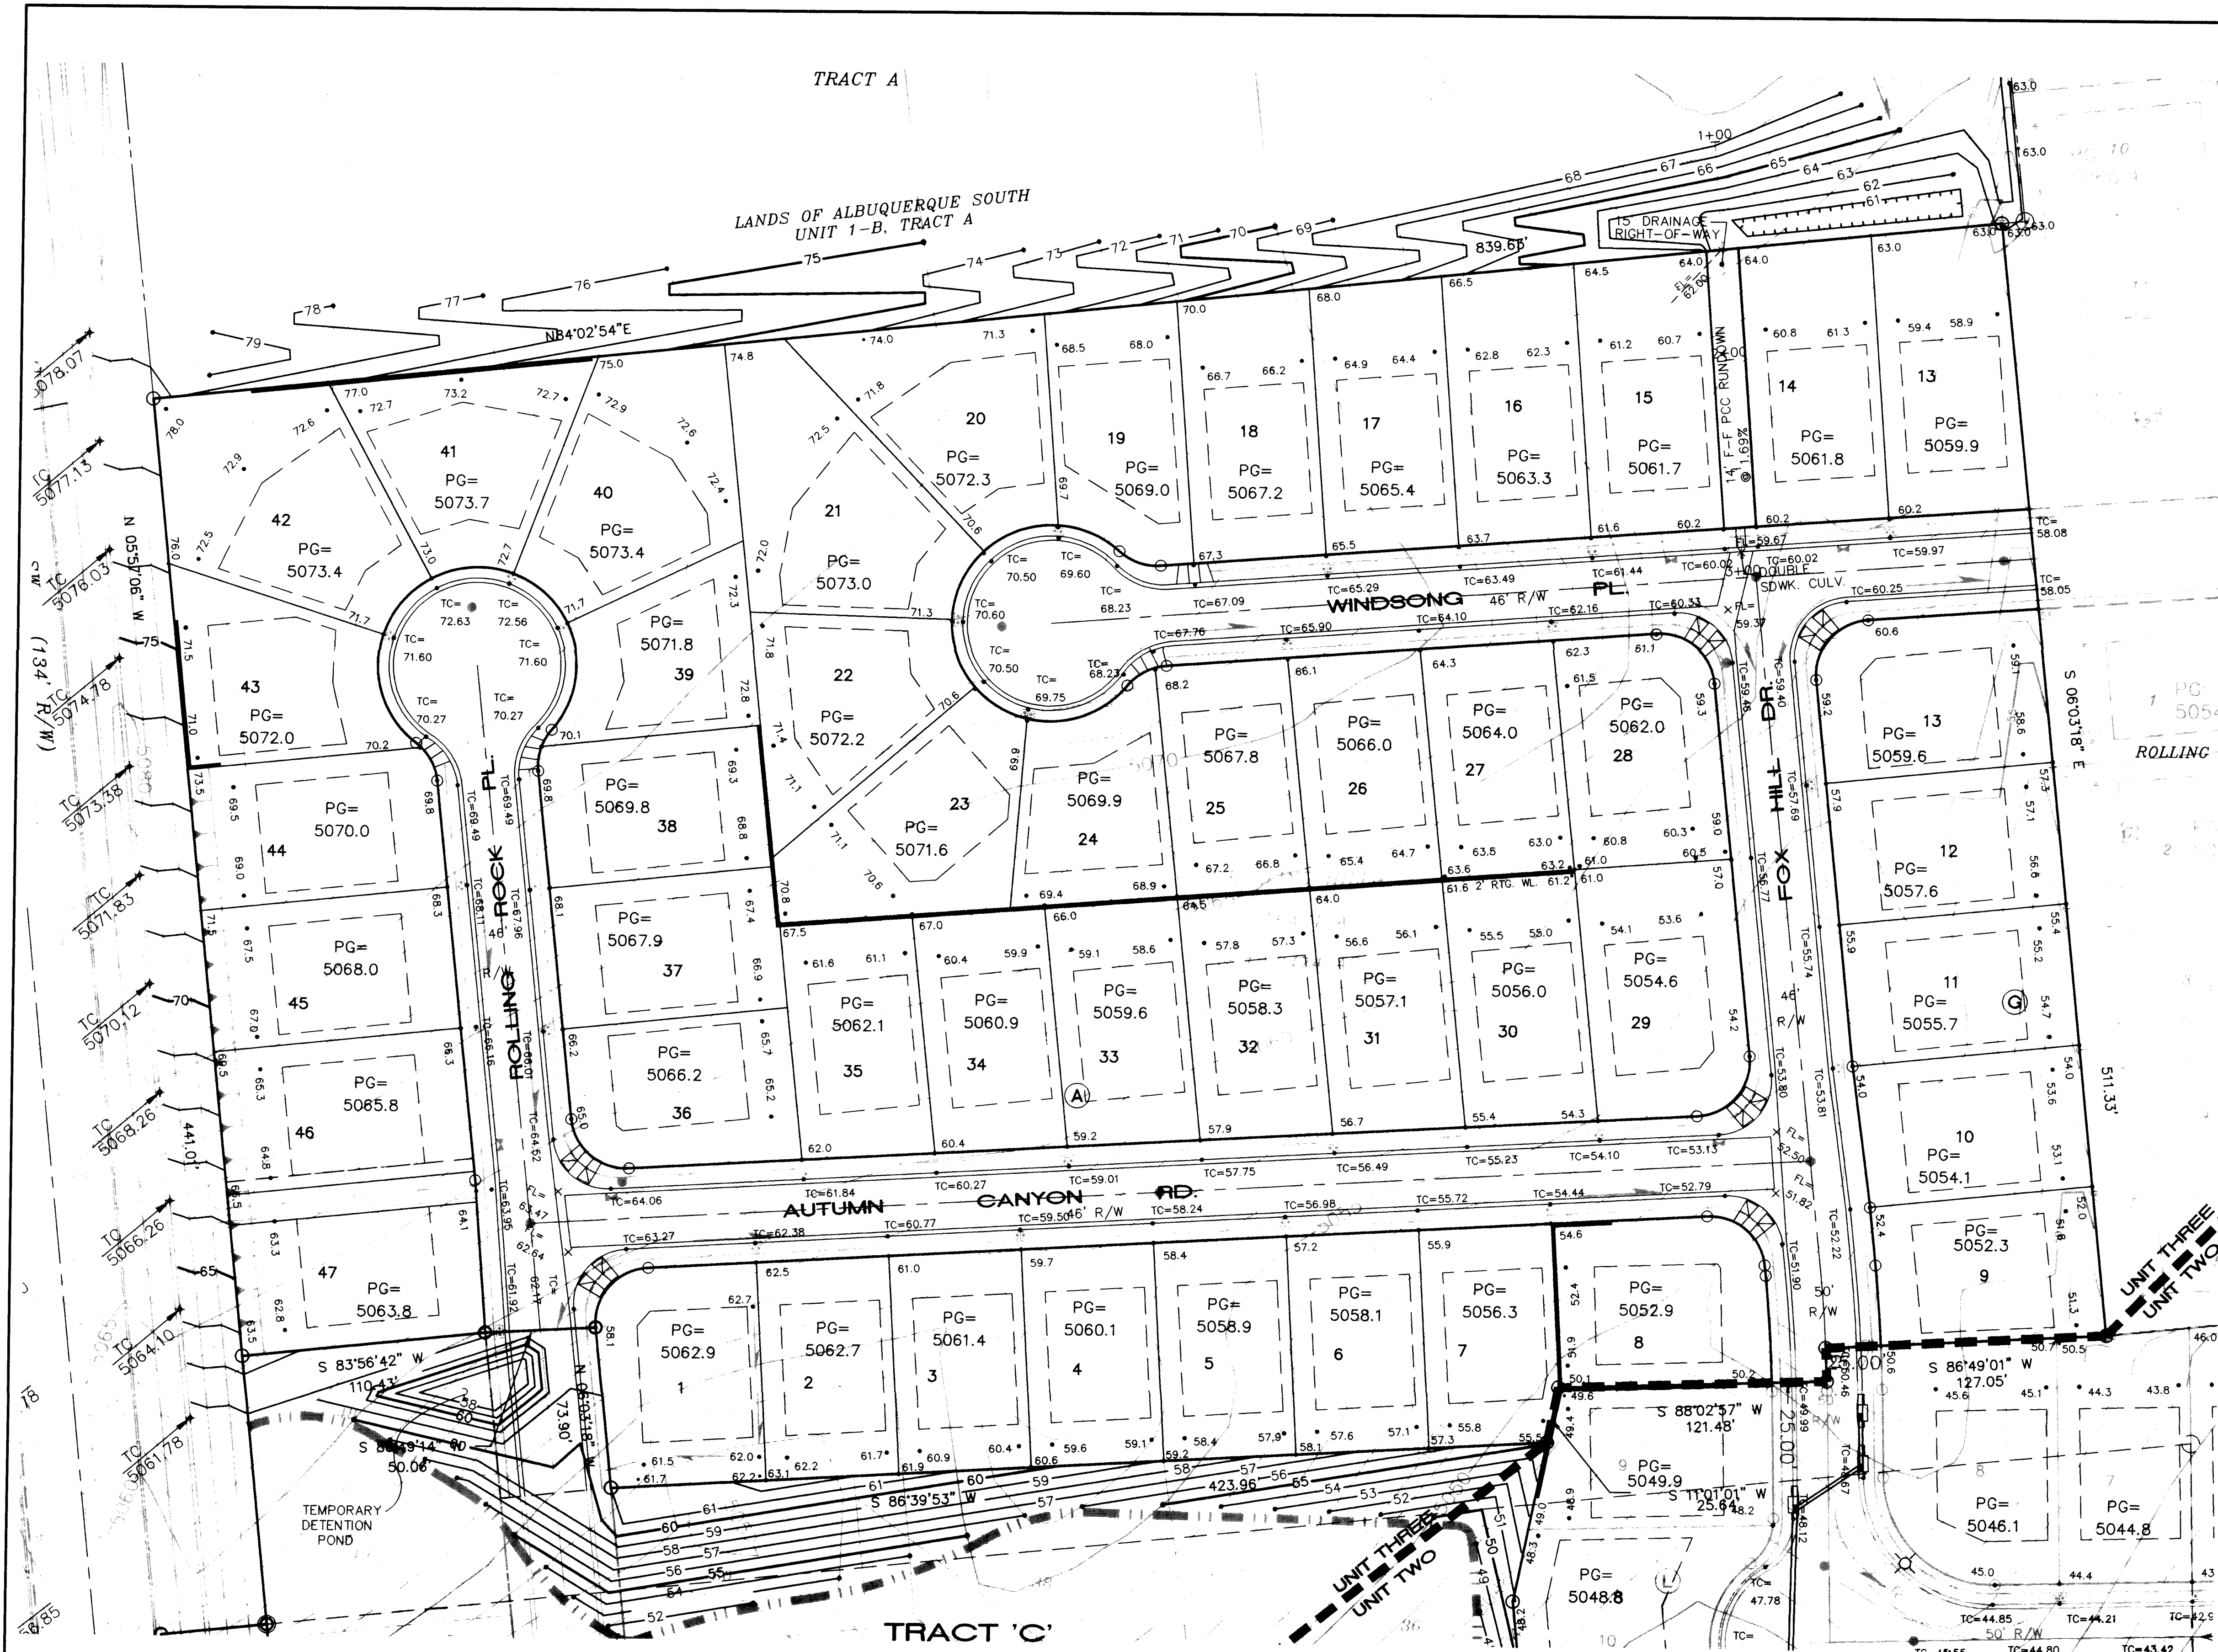

- LEGEND**
- EXIST. CONTOUR INTERVAL
 - 56 FINISHED CONTOUR
 - EXIST. SPOT ELEV.
 - 53.2 FINISHED SPOT ELEV.
 - TC=52.74 TOP OF CURB ELEV.
 - FL=52.43 FLOWLINE ELEV.
 - PG=5052.3 PAD GRADE ELEV.
 - RETAINING WALL
 - UNIT BOUNDARY
 - FUTURE INFRASTRUCTURE
 - EROSION CONTROL BERM

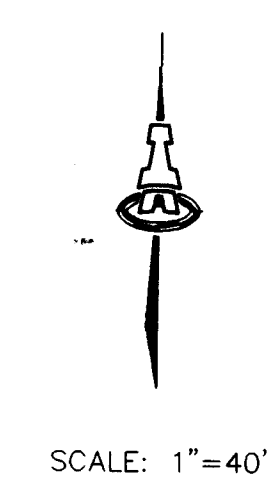

APPROVAL FOR ROUGH GRADING (+/-0.1')
CONDITION: TOP SOIL DISTURBANCE PERMIT
REQUIRED PRIOR TO COMMENCING
EARTHWORK OPERATIONS

HYDROLOGY DIVISION
PUBLIC WORKS DEPARTMENT
CITY OF ALBUQUERQUE

DATE


ENGINEER'S CERTIFICATION

ISAACSON & ARFMAN, P.A.
Consulting Engineering Associates
128 Monroe Street N.E.
Albuquerque New Mexico


917430RD.DWG 05/05/97

CITY OF ALBUQUERQUE PUBLIC WORKS DEPARTMENT ENGINEERING GROUP	
TITLE: ROLLING HILLS SUBDIVISION--UNIT 3 GRADING & DRAINAGE PLAN	
Design Review Committee	City Engineer Approval
City Project No. 5379.92	Zone Map No. M-10
Sheet 3 Of 14	

AS-BUILT INFORMATION		BENCH MARKS		SURVEY INFORMATION		FIELD NOTES	
CONTRACTOR	FRANKLINS	DATE	97	STATION	1/96	ALB	1
WORK	ALB	DATE	97	STATION	1/96	ALB	1
STATION	ALB	DATE	97	STATION	1/96	ALB	1
DATE	97	DATE	97	STATION	1/96	ALB	1
DATE	97	DATE	97	STATION	1/96	ALB	1
DATE	97	DATE	97	STATION	1/96	ALB	1
DATE	97	DATE	97	STATION	1/96	ALB	1
DATE	97	DATE	97	STATION	1/96	ALB	1
DATE	97	DATE	97	STATION	1/96	ALB	1
DATE	97	DATE	97	STATION	1/96	ALB	1

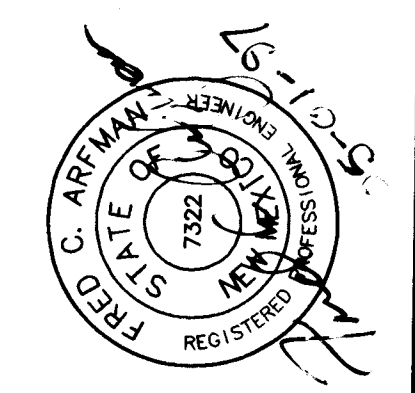

SCANNED BY
BY LASON


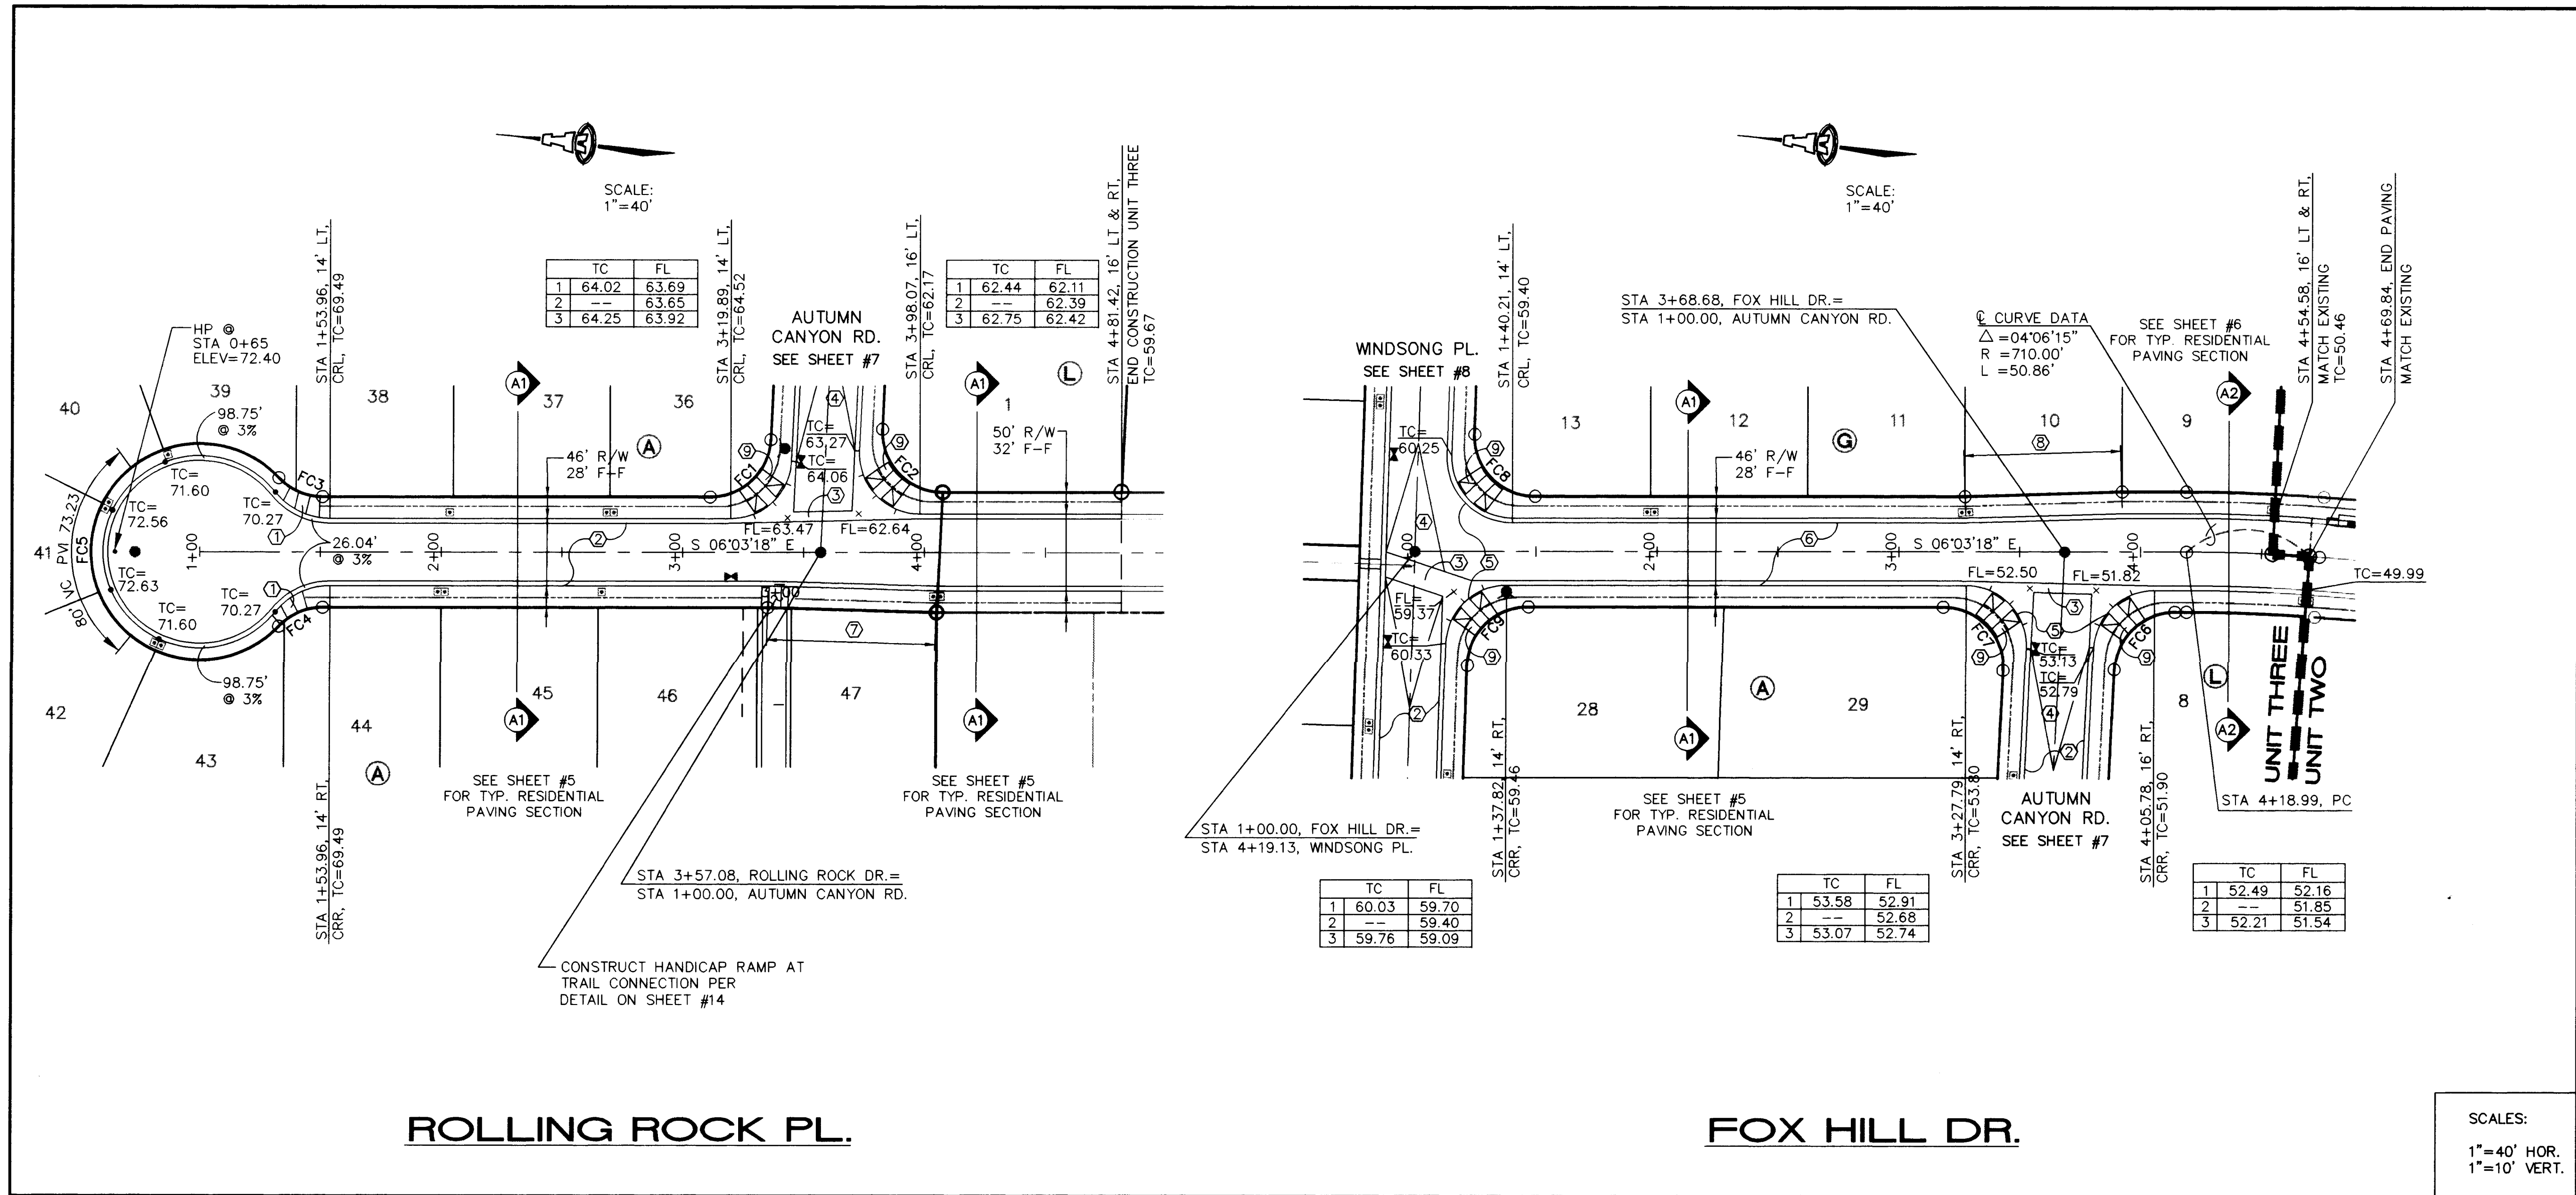


KEYED CONSTRUCTION NOTES

1. CONSTRUCT HANDICAP RAMP PER COA STD DWG #2441.
2. MOUNTABLE CURB & GUTTER PER COA STD DWG #2415.
3. CONSTRUCT PCC VALLEY GUTTER 4' WIDE, 3/4" INVERT PER COA STD DWG #2420.
4. CROWN TO NO CROWN TRANSITION 50' MIN. LENGTH.
5. TRANSITION FROM MOUNTABLE TO STANDARD CURB PER COA STD DWG #2418.
6. STANDARD CURB & GUTTER PER COA STD DWG #2415.
7. TRANSITION FROM 46' R/W, 28' F-F, TO 50' R/W, 32' F-F, FROM STA 3+35.28 TO STA 4+05.00, RIGHT.
8. TRANSITION FROM 46' R/W, 28' F-F, TO 50' R/W, 32' F-F, FROM STA 3+27.64 TO STA 3+92.50, LEFT.
9. CONSTRUCT HANDICAP RAMP PER DETAIL ON SHEET #5.

FACE OF CURB CURVE TABLE

CURVE	RADIUS	LENGTH	DELTA
FC1	25.00'	38.08'	87°16'49"
FC2	25.00'	40.46'	92°43'11"
FC3	29.00'	26.04'	51°27'02"
FC4	29.00'	26.04'	51°27'02"
FC5	40.00'	197.50'	282°54'05"
FC6	25.00'	38.08'	87°16'49"
FC7	25.00'	40.46'	92°43'11"
FC8	25.00'	40.04'	91°45'21"
FC9	25.00'	38.50'	88°14'39"

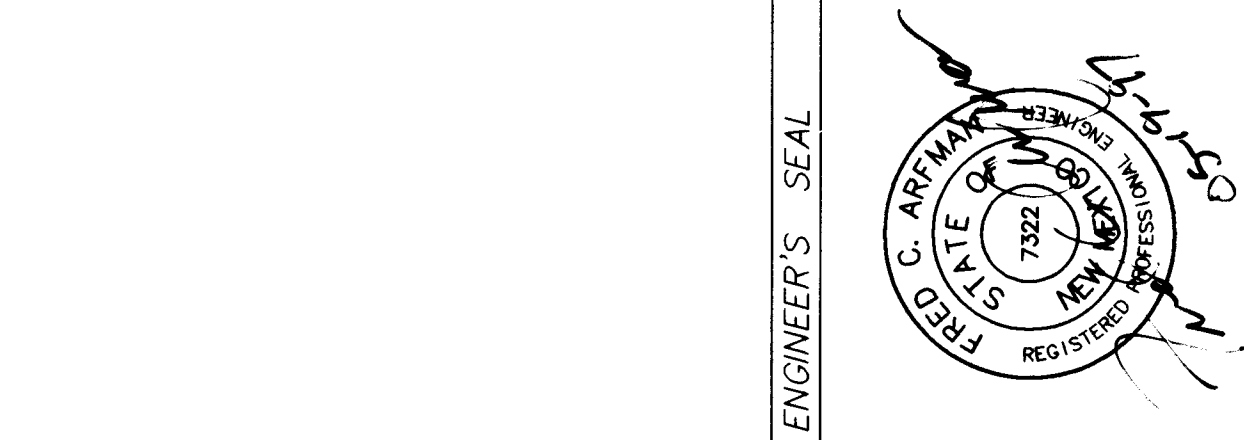
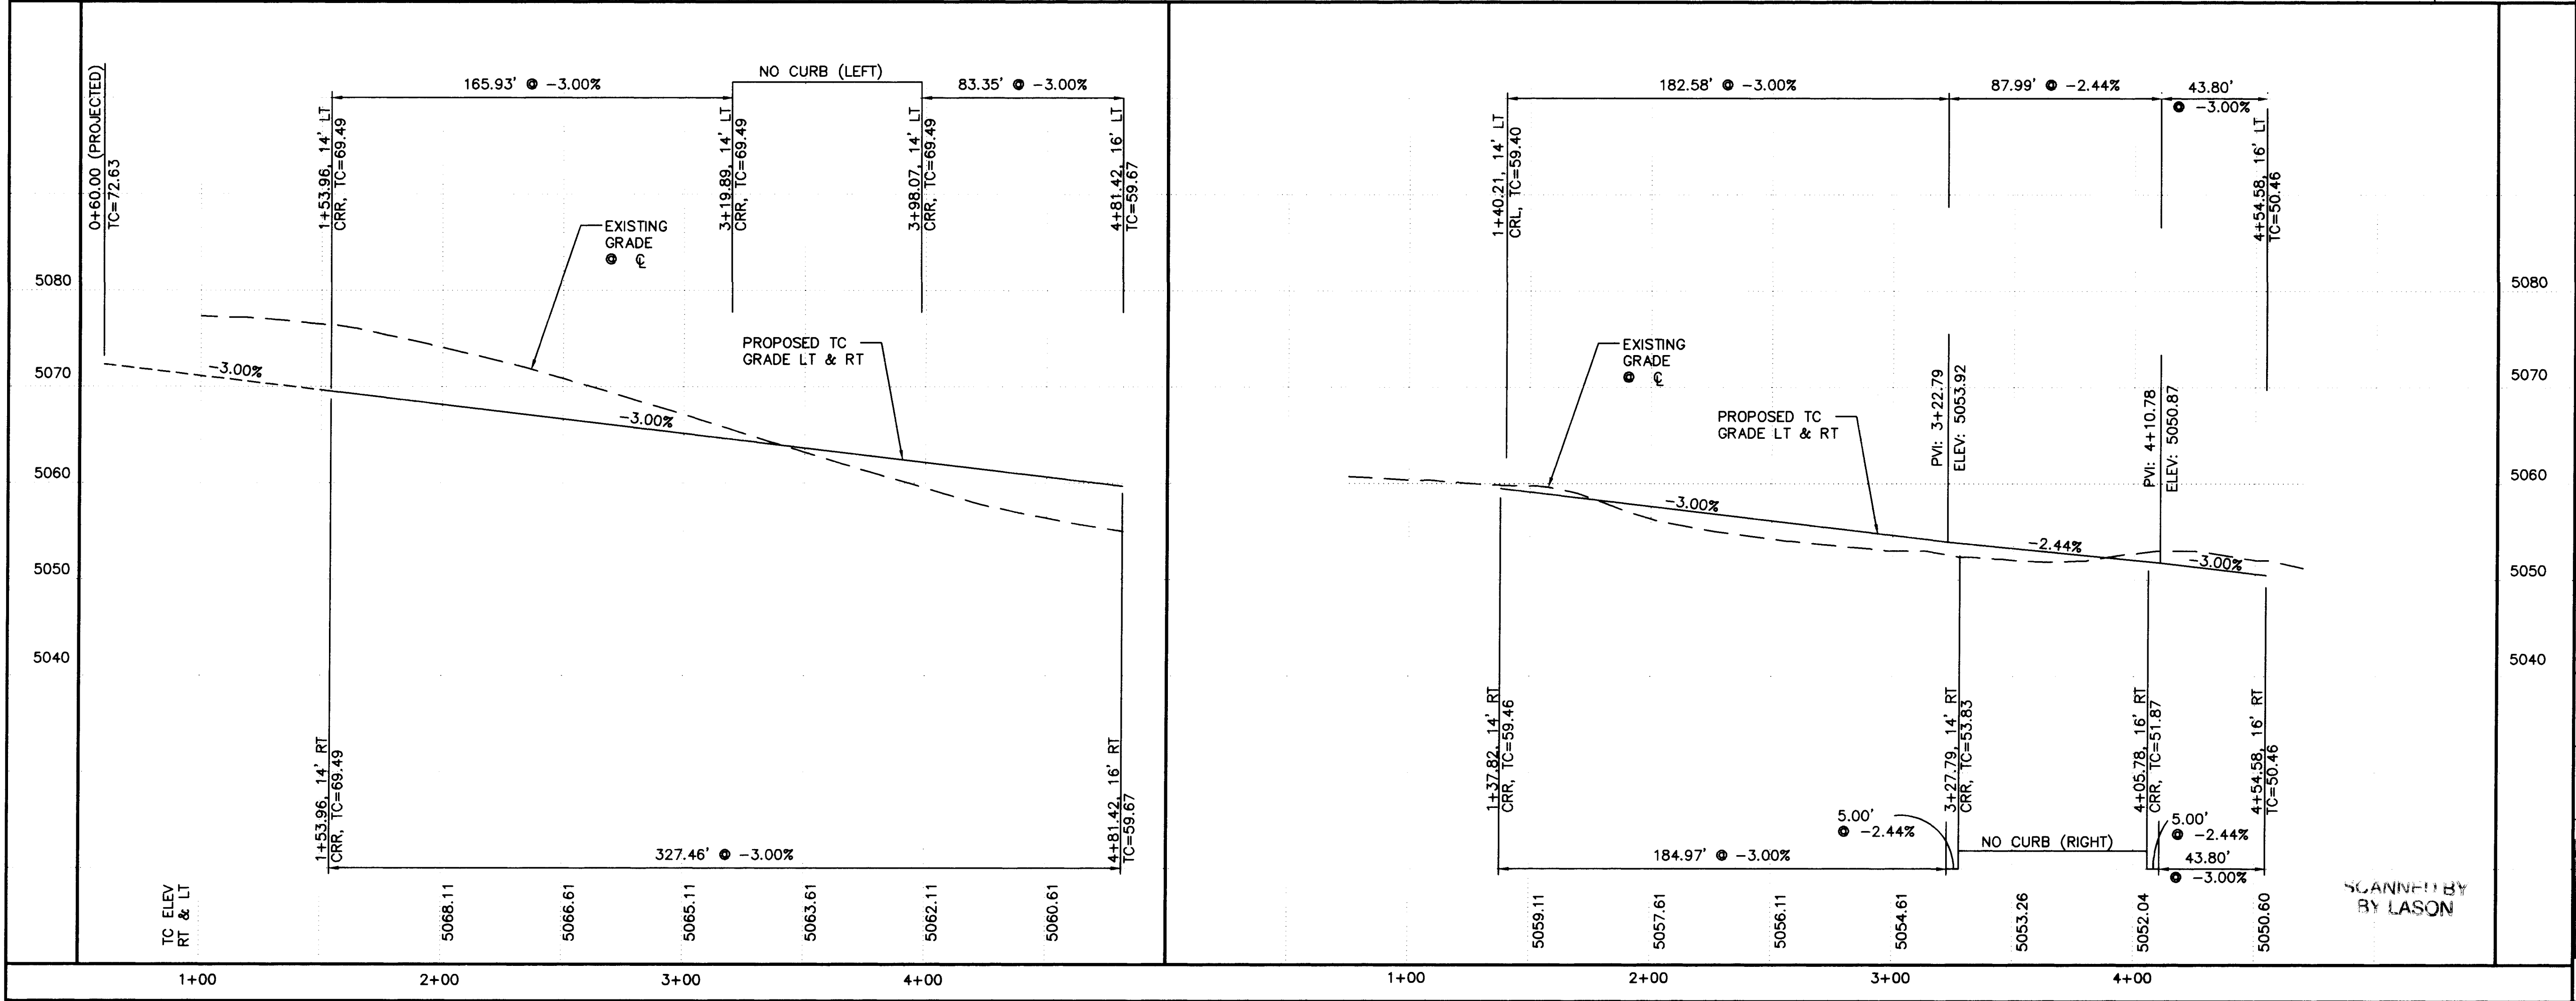


ISAACSON & ARFMAN, P.A.
Consulting Engineering Associates
128 Monroe Street N.E.
Albuquerque New Mexico
917PV1.DWG 04/30/97

CITY OF ALBUQUERQUE
PUBLIC WORKS DEPARTMENT
ENGINEERING GROUP

TITLE: ROLLING HILLS SUBDIVISION--UNIT 3
ROLLING ROCK PL. & FOX HILL DR.
PAVING PLAN & PROFILE

Design Review Committee	City Engineer Approval	Mo./Day/Yr.	Mo./Day/Yr.

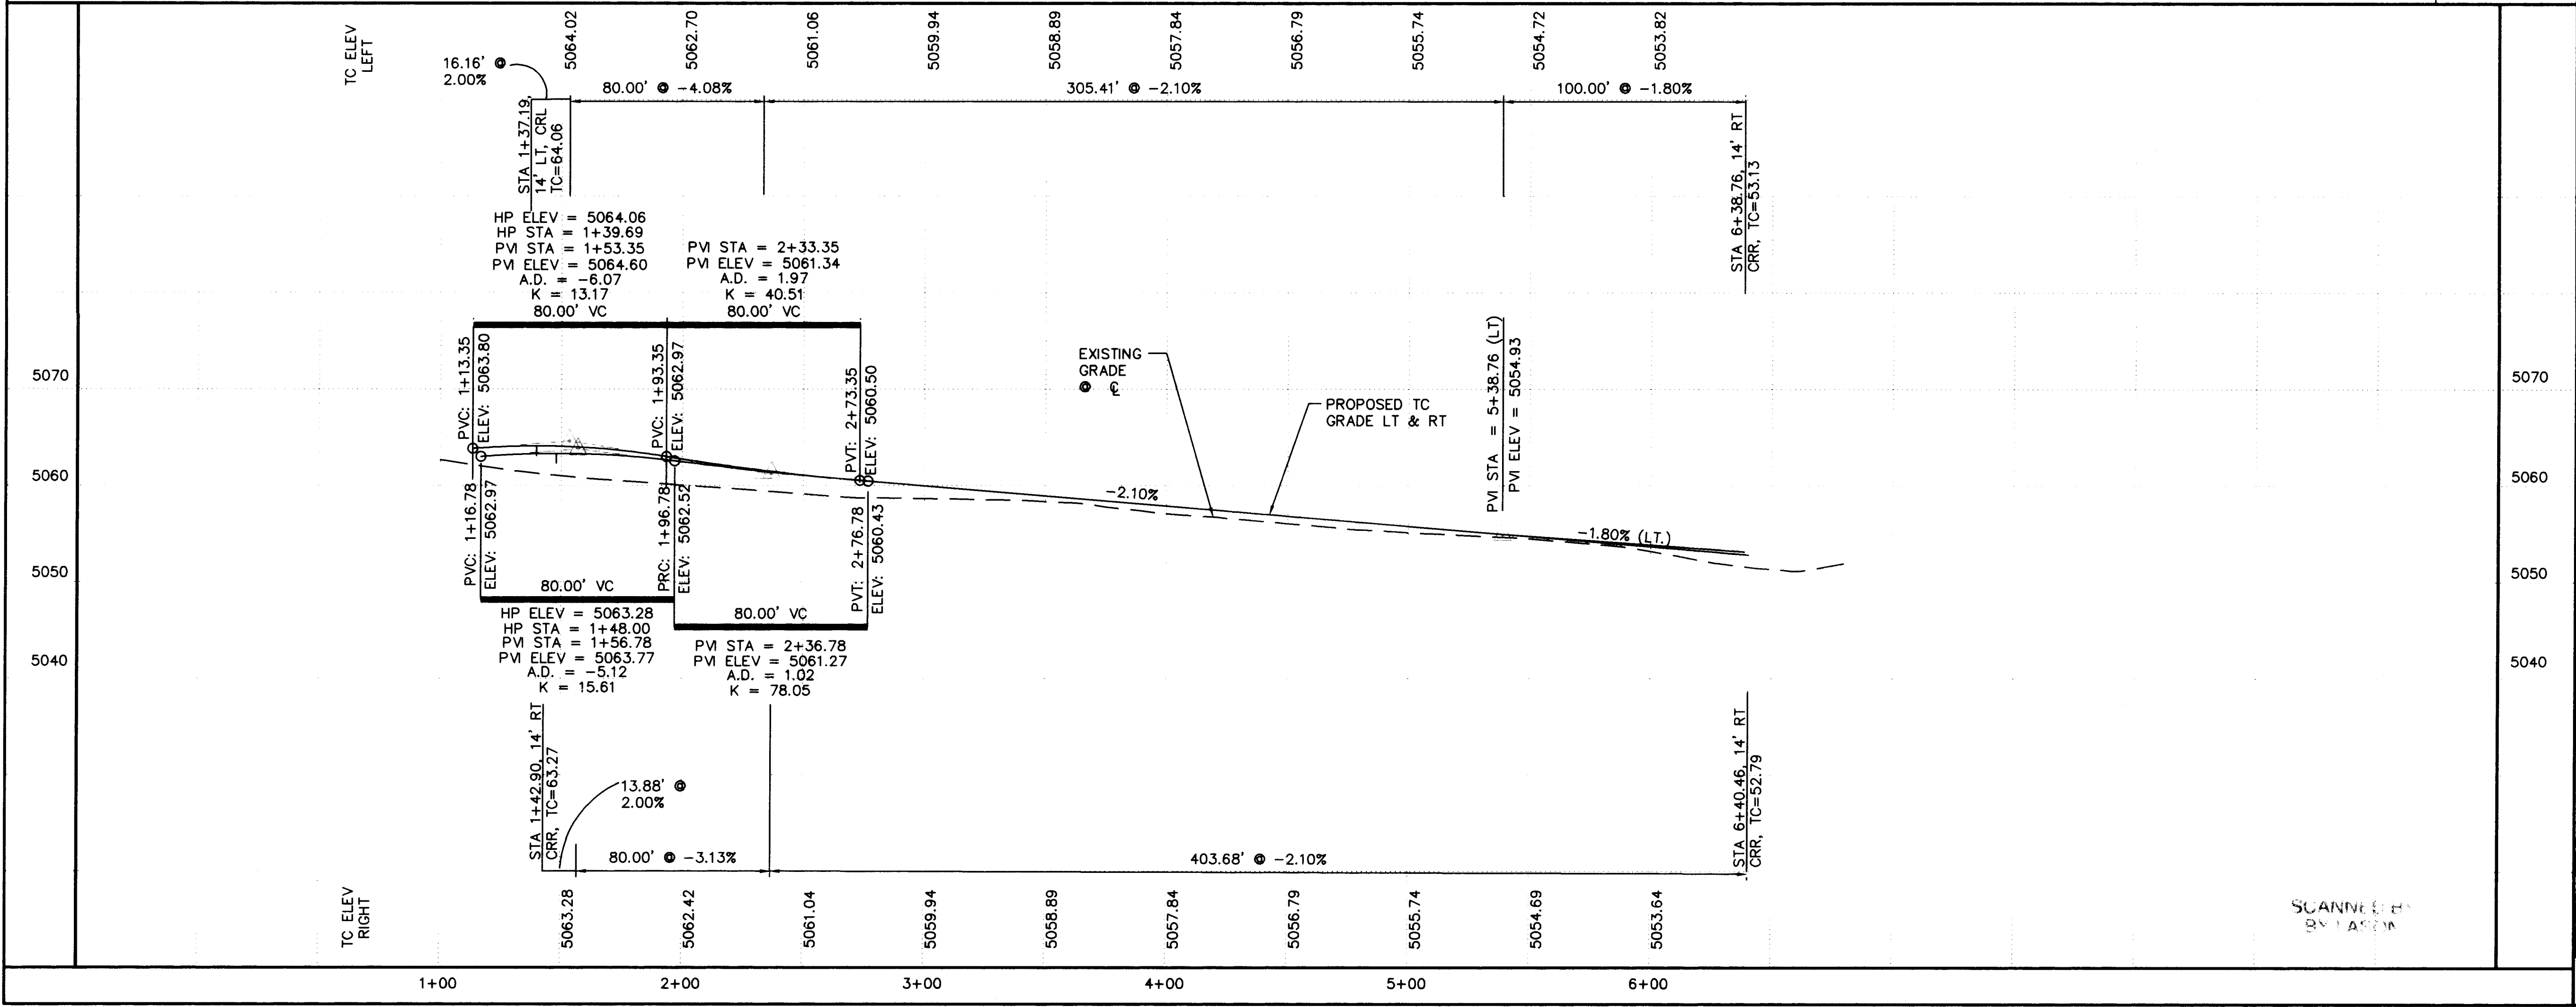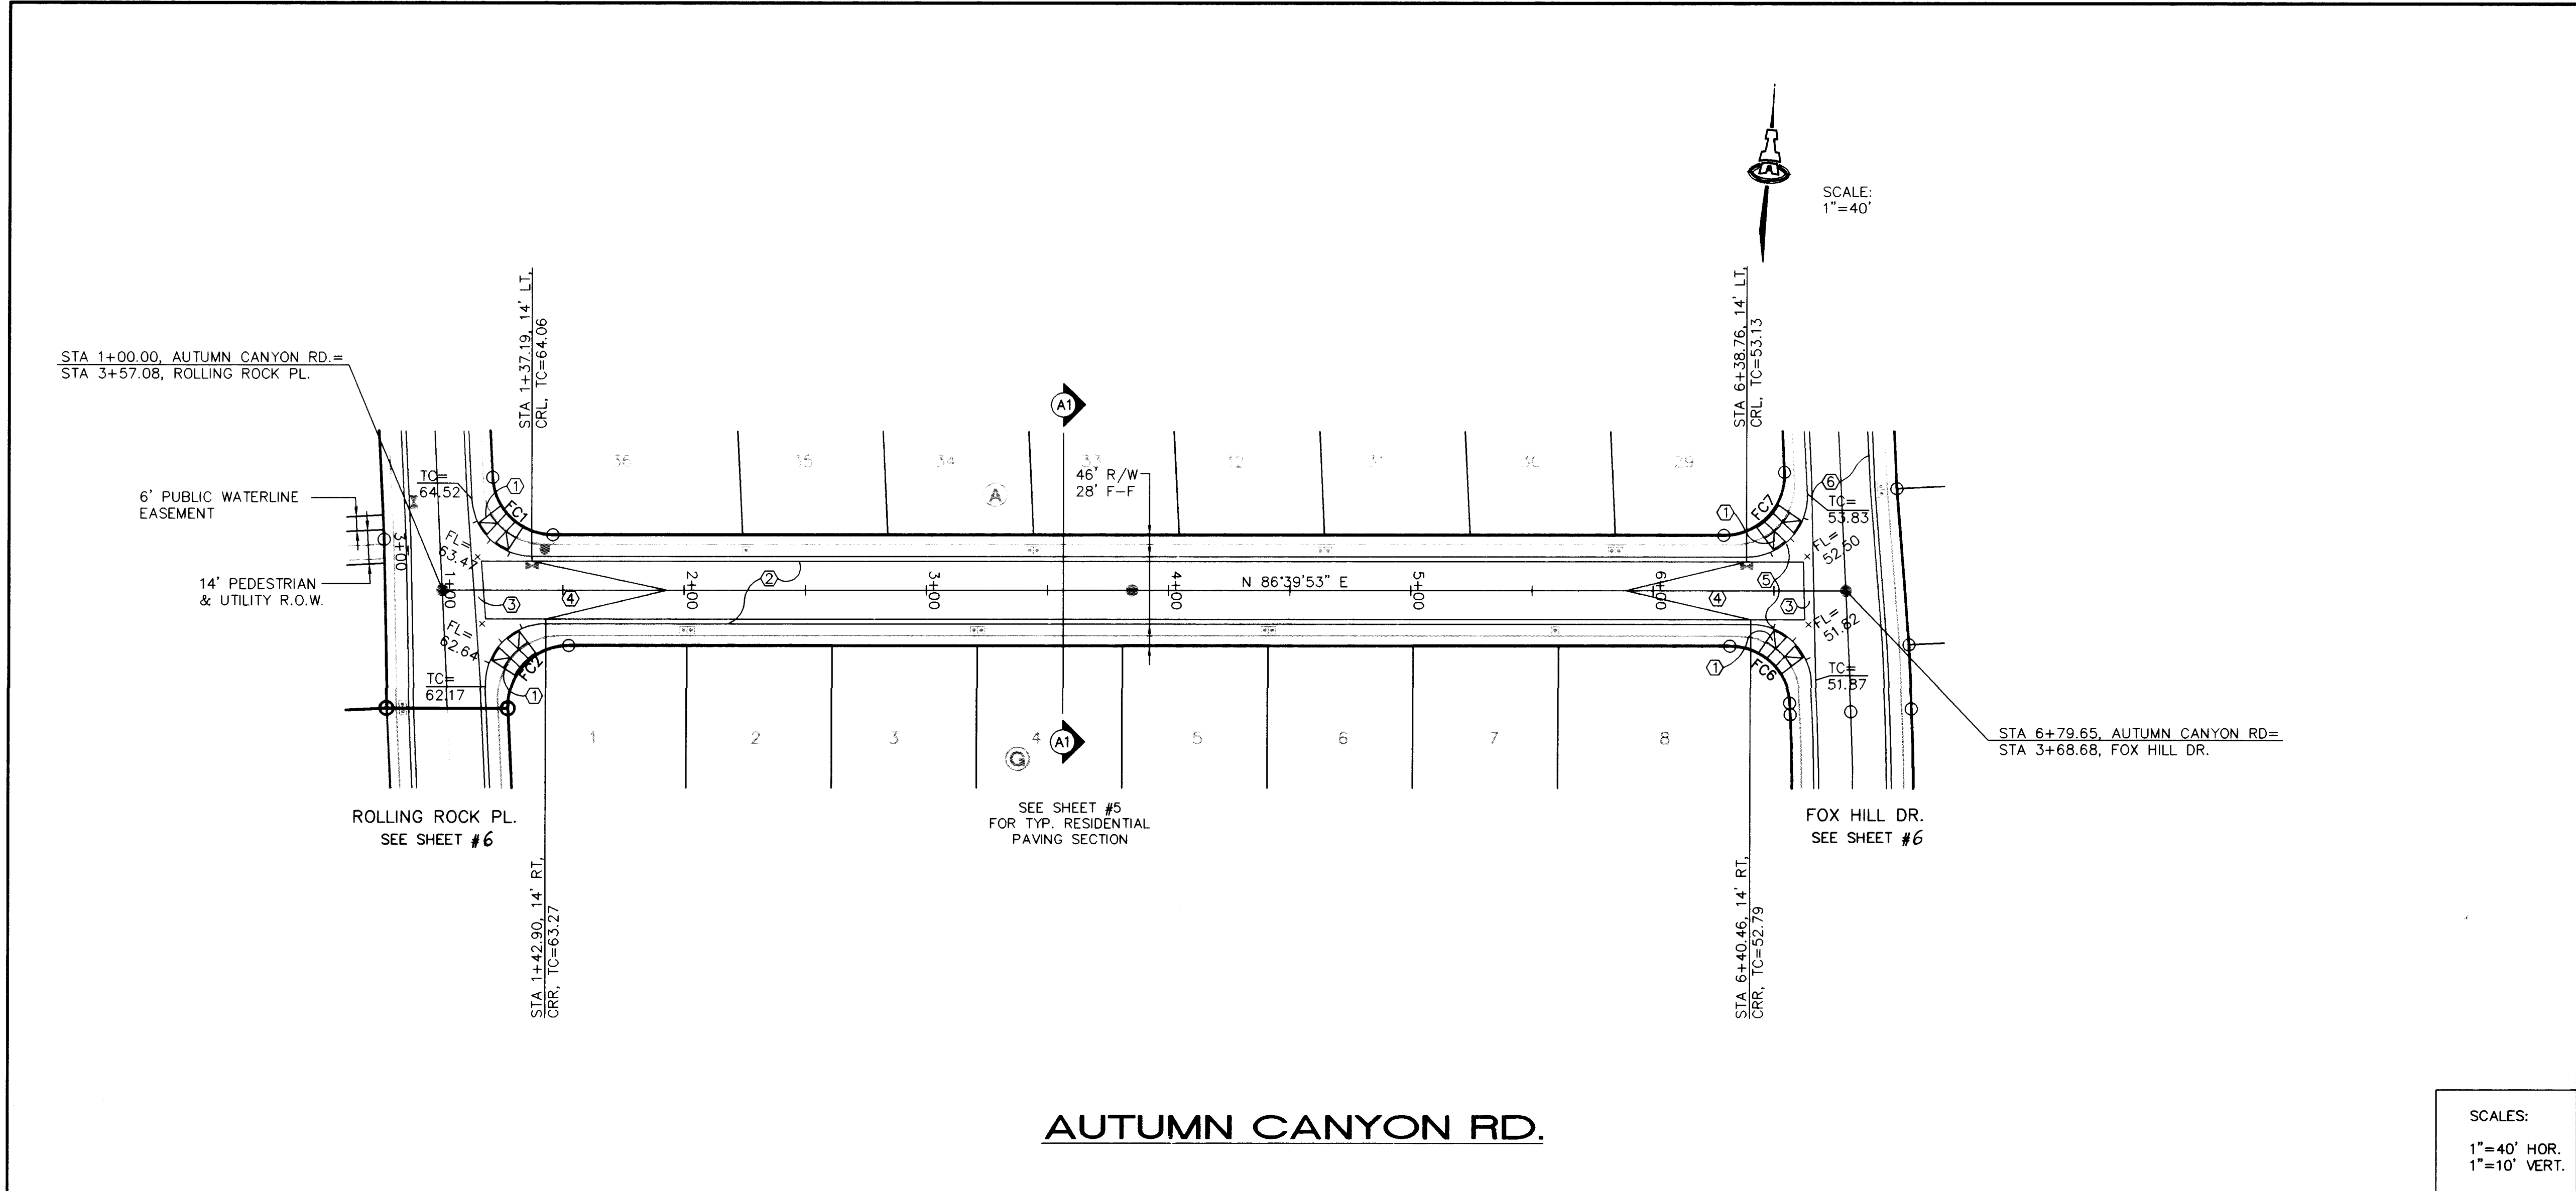

- KEYED CONSTRUCTION NOTES**
1. CONSTRUCT HANDICAP RAMP PER DETAIL ON SHEET #5.
 2. MOUNTABLE CURB & GUTTER PER COA STD DWG #2415.
 3. CONSTRUCT PCC VALLEY GUTTER 4' WIDE, 3/4" INVERT PER COA STD DWG #2420.
 4. CROWN TO NO CROWN TRANSITION 50' MIN. LENGTH.
 5. TRANSITION FROM MOUNTABLE TO STANDARD CURB PER COA STD DWG #2418.
 6. STANDARD CURB & GUTTER PER COA STD DWG #2415.

FACE OF CURB CURVE TABLE

CURVE	RADIUS	LENGTH	DELTA
FC1	25.00'	38.08'	87°16'49"
FC2	25.00'	40.46'	92°43'11"
FC6	25.00'	38.08'	87°16'49"
FC7	25.00'	40.46'	92°43'11"

SCALES:
1"=40' HOR.
1"=10' VERT.

ISAACSON & ARFMAN, P.A.
Consulting Engineering Associates
128 Monroe Street N.E.
Albuquerque, New Mexico
917PV2.DWGaw 05/06/07

CITY OF ALBUQUERQUE
PUBLIC WORKS DEPARTMENT
ENGINEERING GROUP

TITLE: **ROLLING HILLS SUBDIVISION--UNIT 3
AUTUMN CANYON RD.
PAVING PLAN & PROFILE**

Design Review Committee	City Engineer Approval	Mo./Day/Yr.	Mo./Day/Yr.

City Project No. 5379.92	Zone Map No. M-10	Sheet 7	Of 14
------------------------------------	-----------------------------	-------------------	-----------------

ENGINEER'S SEAL:

NO.	DATE	REVISIONS	BY
1	3/97	DESIGN	FCA
2	3/97	ANW	ANW
3	3/97	I&A	I&A

AS-BUILT INFORMATION

CONTRACTOR	FRANKLINS
WORK BY	ALFONSO
INSPECTOR'S ACCEPTANCE BY	ALFONSO
REVISION BY	ALFONSO
DATE	05/06/07

SURVEY INFORMATION



FIELD NOTES	1/96	ALS
1		

BENCH MARKS

ACS MONUMENT "1-MI" LOCATED AT THE SOUTHEAST CORNER OF SAGE RD. & UNSEER BLVD.	
ELEV. = 5079.88	

MICRO-FILM INFORMATION

RECORDED BY	
DATE	

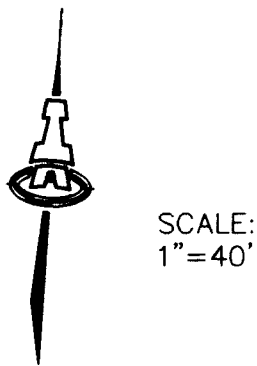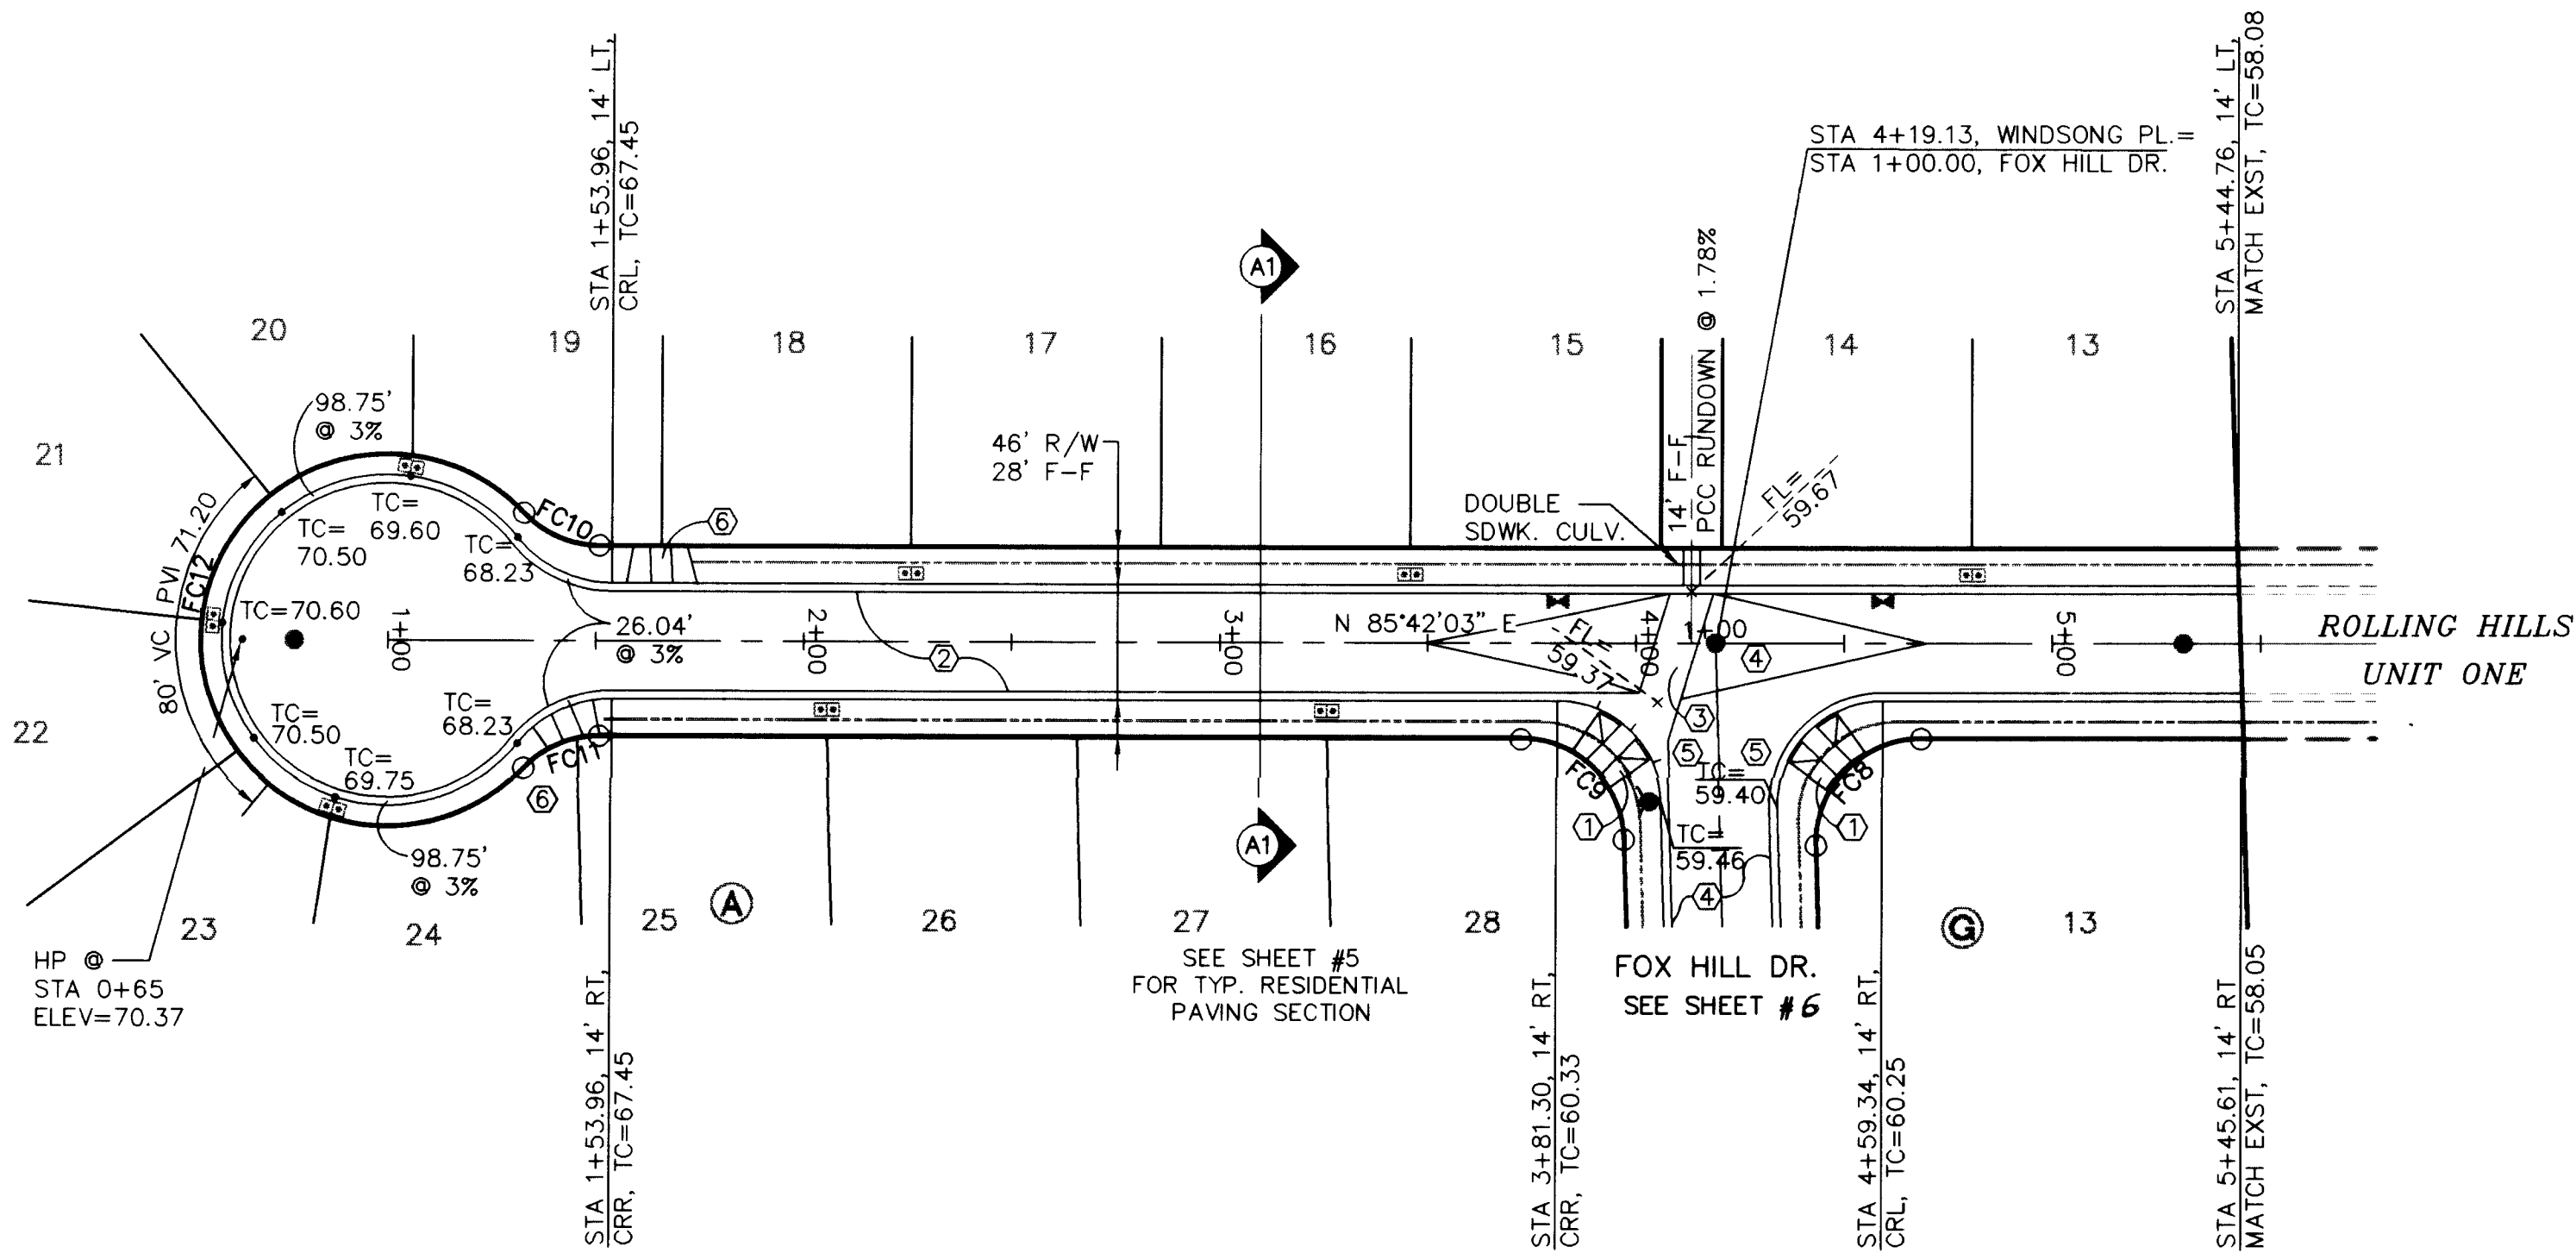


KEYED CONSTRUCTION NOTES

1. CONSTRUCT HANDICAP RAMP PER DETAIL ON SHEET #5.
2. MOUNTABLE CURB & GUTTER PER COA STD DWG #2415.
3. CONSTRUCT PCC VALLEY GUTTER 10' WIDE, 3/4" INVERT PER COA STD DWG #2420 (MODIFIED FOR 10' WIDTH).
4. STANDARD CURB & GUTTER PER COA STD DWG #2415.
5. TRANSITION FROM MOUNTABLE TO STANDARD CURB PER COA STD DWG #2418.
6. CONSTRUCT HANDICAP RAMP PER COA STD DWG #2441.

FACE OF CURB CURVE TABLE

CURVE	RADIUS	LENGTH	DELTA
FC8	25.00'	40.04'	91°45'21"
FC9	25.00'	38.50'	88°14'39"
FC10	29.00'	26.04'	51°27'02"
FC11	29.00'	26.04'	51°27'02"
FC12	40.00'	197.50'	282°54'05"

SCALES:
1"=40' HOR.
1"=10' VERT.

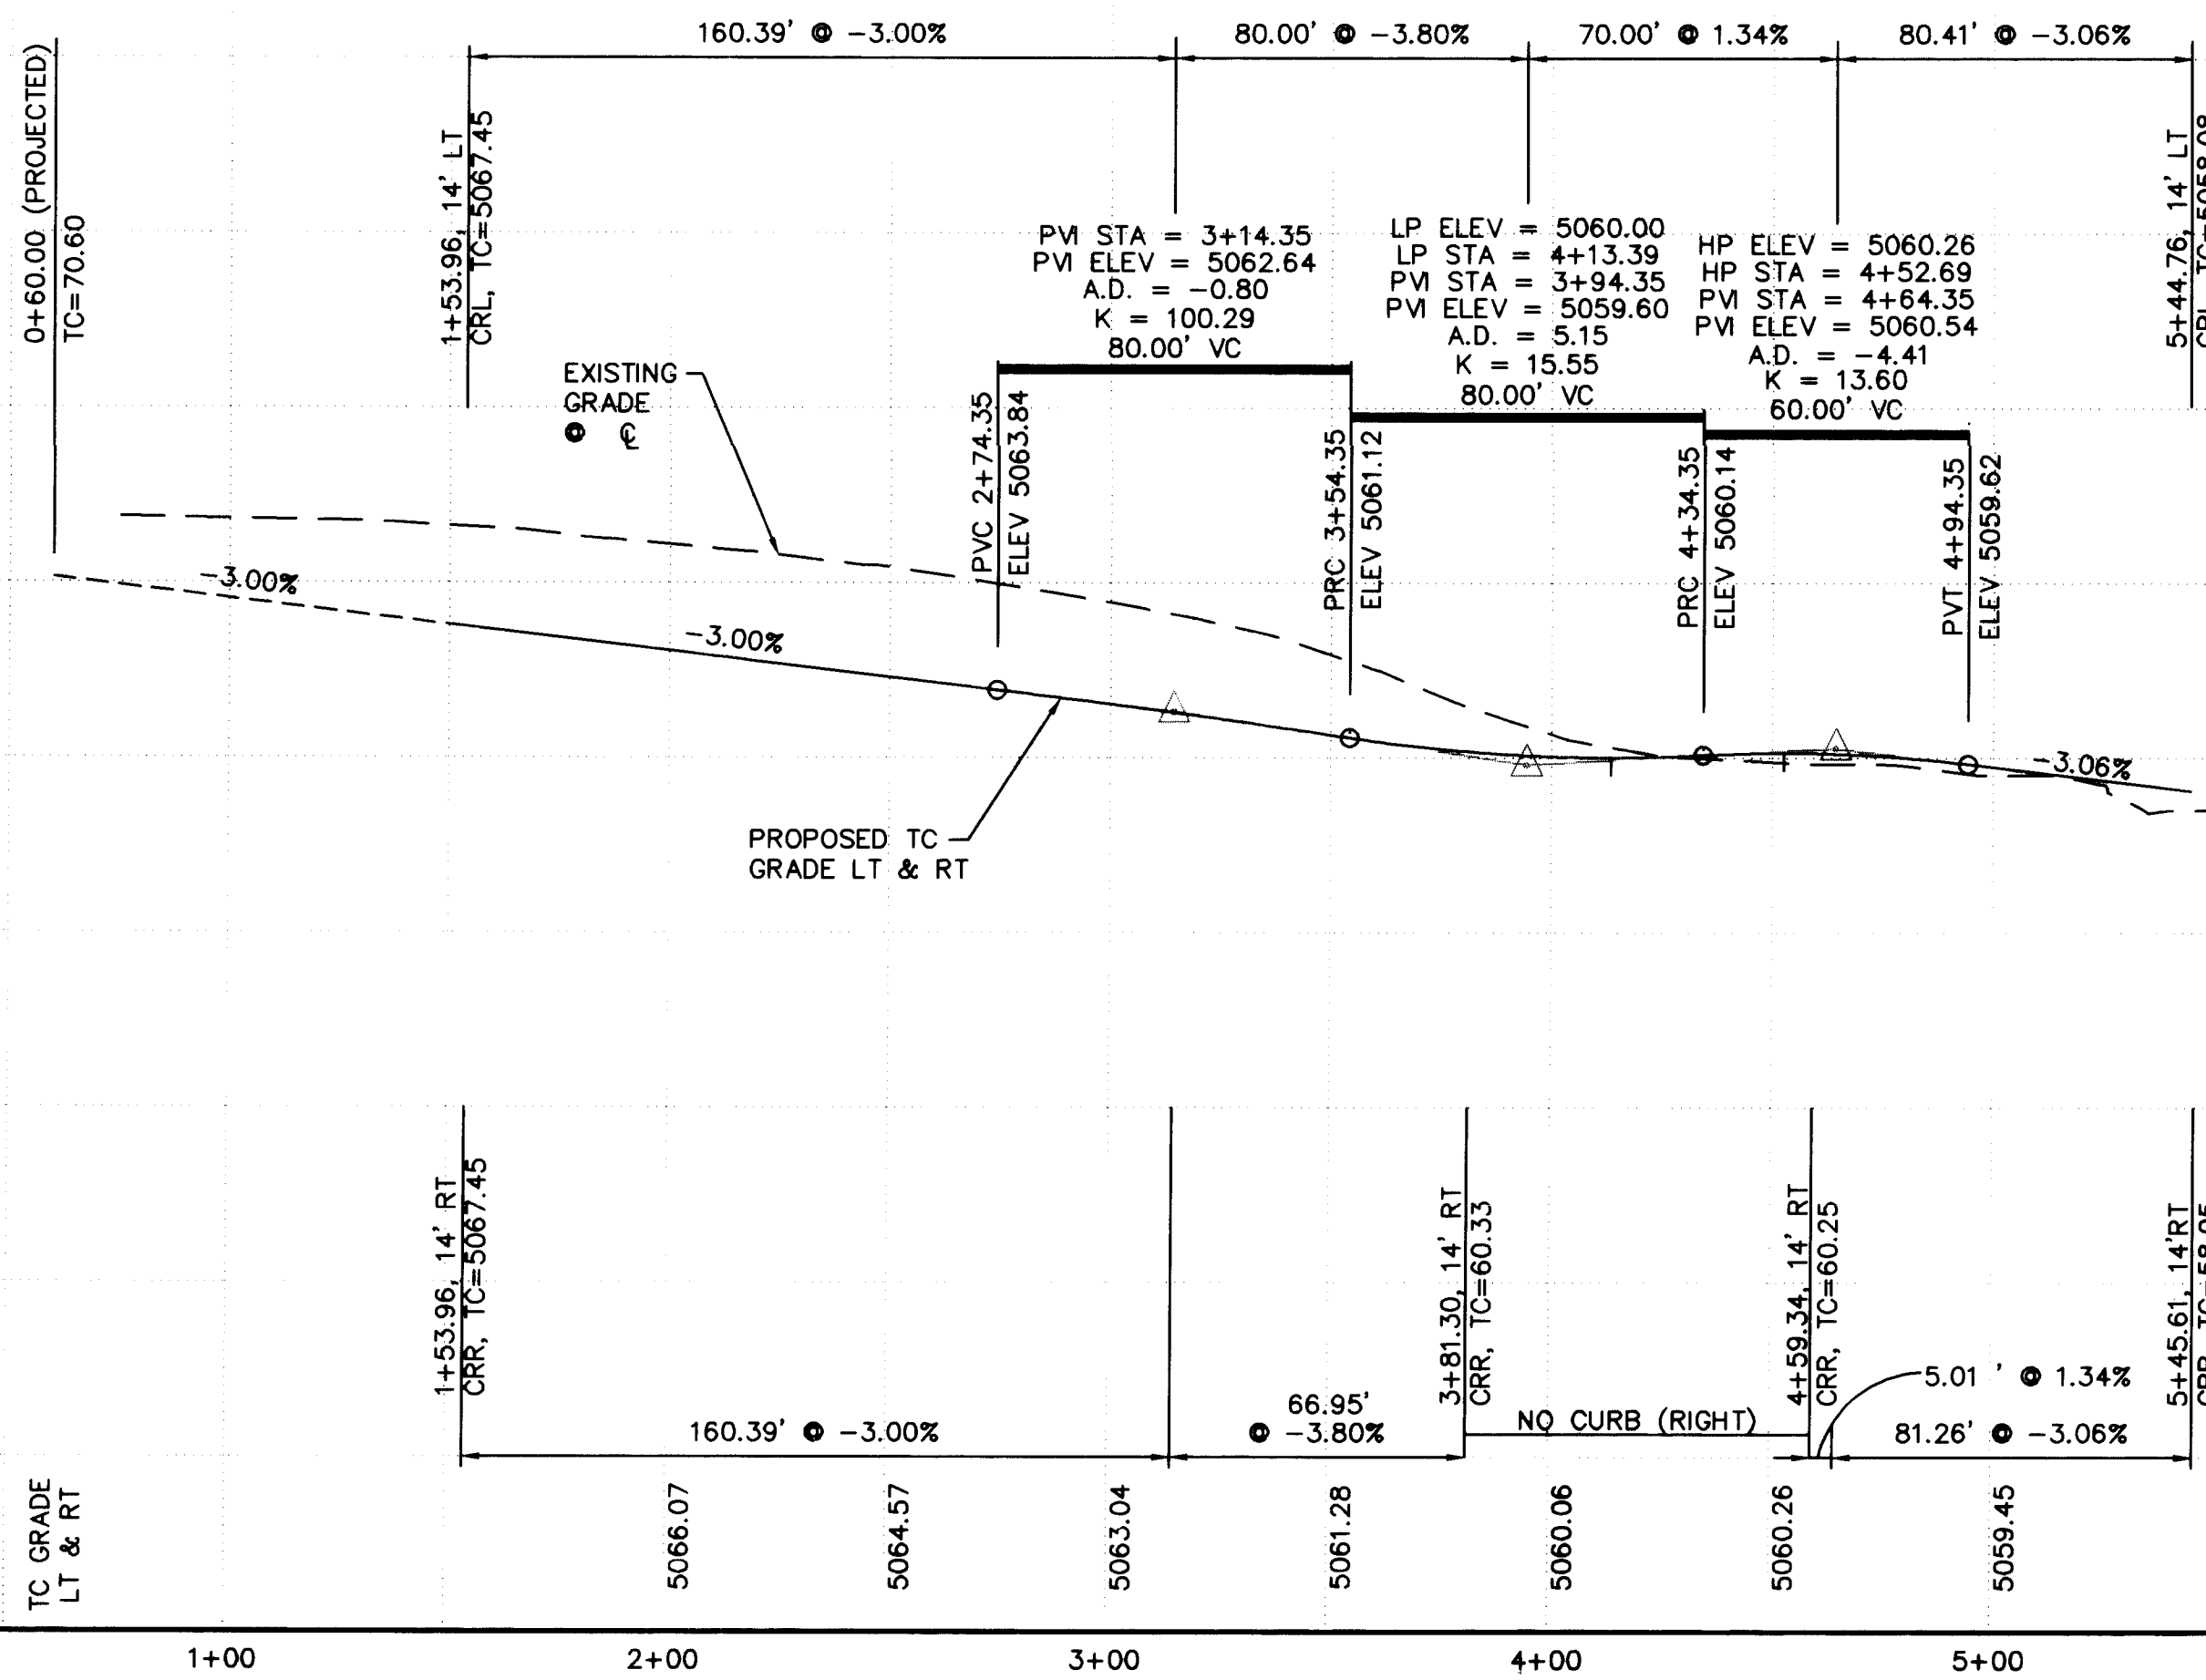


AS-BUILT INFORMATION	
CONTRACTOR	FRANKLIN
DATE	9/97
INSPECTOR	ALS
DATE	9/97
FIELD	ALS
DATE	9/97
REVISION	ALS
DATE	9/97
CORRECTED BY	ALS
DATE	9/97
MICRO-FILM INFORMATION	
RECORDED BY	
DATE	
NO.	

BENCH MARKS	
ACS MONUMENT "1-M10" LOCATED AT THE SOUTHEAST CORNER OF SAGE RD. & UNSER BLVD.	
ELEV. = 5079.88	

SURVEY INFORMATION	
FIELD NOTES	
1	ALS
1/96	

ENGINEER'S SEAL	
NO.	DATE
REVISIONS	BY
DESIGN	
DATE	3/97
DRAWN BY	ANW
DATE	3/97
CHECKED BY	I&A
DATE	3/97

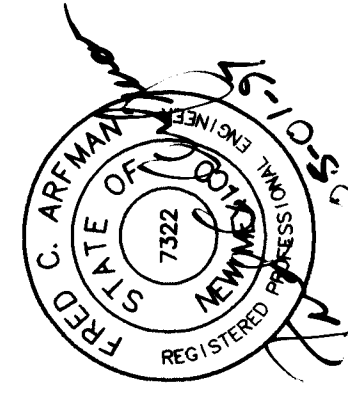


ISAACSON & ARFMAN, P.A.
Consulting Engineering Associates
128 Monroe Street N.E.
Albuquerque New Mexico
917PV3.DWGanw 04/30/97

CITY OF ALBUQUERQUE
PUBLIC WORKS DEPARTMENT
ENGINEERING GROUP

TITLE: ROLLING HILLS SUBDIVISION--UNIT 3
WINDSONG PL.
PAVING PLAN & PROFILE

City Project No.	Zone Map No.	Sheet	Of
5379.92	M-10	8	14

 

SHUT-OFF VALVES ① & ② TO PROVIDE NON-PRESSURE CONNECTION. THE CONTRACTOR SHALL CONTACT WATER SYSTEMS DIVISION (857-8200) 5 WORKING DAYS PRIOR TO SHUT-OFF OR TURN-ON AT VALVES. ONLY CITY PERSONNEL ARE ALLOWED TO OPERATE VALVES.

	SINGLE WATER METER & BOX
	DOUBLE WATER METER & BOX
	GATE VALVE W/ TYPE 'A' VALVE BOX
	FIRE HYDRANT
	SAS MANHOLE
	WATER LINE W/ FITTING



RESTRAINED JOINT LENGTHS, L_T , FOR REDUCERS, (FT.) MINIMUM UNOBSTRUCTED, STRAIGHT-RUN LENGTH: RESTRAIN EITHER LARGE PIPE, OR SMALL PIPE.					
SIZE	LARGE SIDE	SMALL SIDE	SIZE	LARGE SIDE	SMALL SIDE
12x10	25	30	10x6	44	73
12x8	45	68	10x4	58	141
12x6	62	121	8x6	25	33
12x4	74	213	8x4	4.3	83
10x8	24	30	6x4	24	35


THIS TABLE IS BASED UPON THE FOLLOWING CRITERIA:

DEPTH OF BURY	3.0 FT. MINIMUM
FACTOR OF SAFETY	1.25
MATERIAL	PVC PIPE
SOIL TYPE:	GM/SM - SILTY GRAVELS AND SILTY SANDS, GRAVEL-SAND-SILT MIXTURES.
TEST PRESSURE	150 PSI
TRENCH TYPE 4:	PIPE BEDDED IN SAND, GRAVEL, OR CRUSHED STONE TO DEPTH OF 1/8 PIPE DIAMETER, 4 INCH MINIMUM; BACKFILL COMPACTED TO TOP OF PIPE.

DIFFERENT CRITERIA, E.G., DUCTILE IRON PIPE, GREATER DEPTH OF BURY ETC., WILL REQUIRE DIFFERENT RESTRAINED LENGTHS. THESE MUST BE CALCULATED BY A QUALIFIED PROFESSIONAL ENGINEER AND APPROVED BY THE PUBLIC WORKS DEPARTMENT.

RESTRAINED JOINT LENGTHS FOR WATERLINE FITTINGS

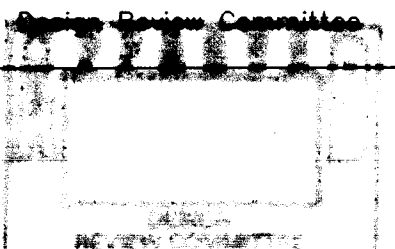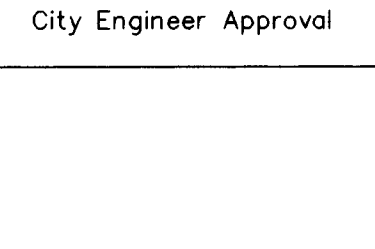	ISAACSON & ARFMAN, P.A. Consulting Engineering Associates 128 Monroe Street N.E. Albuquerque New Mexico							DATE	DESIGNED BY	DRAWN BY	CHECKED BY	
917UMST3.DWG		05/05/97										
CITY OF ALBUQUERQUE PUBLIC WORKS DEPARTMENT ENGINEERING GROUP												
TITLE: ROLLING HILLS SUBDIVISION--UNIT 3 UTILITY MASTER PLAN												
		City Engineer Approval 		Last Design Update	Mo./Day/Yr.		Mo./Day/Yr.					
City Project No. 5379.92				Zone Map No. M-10		Sheet 9 Of 14						

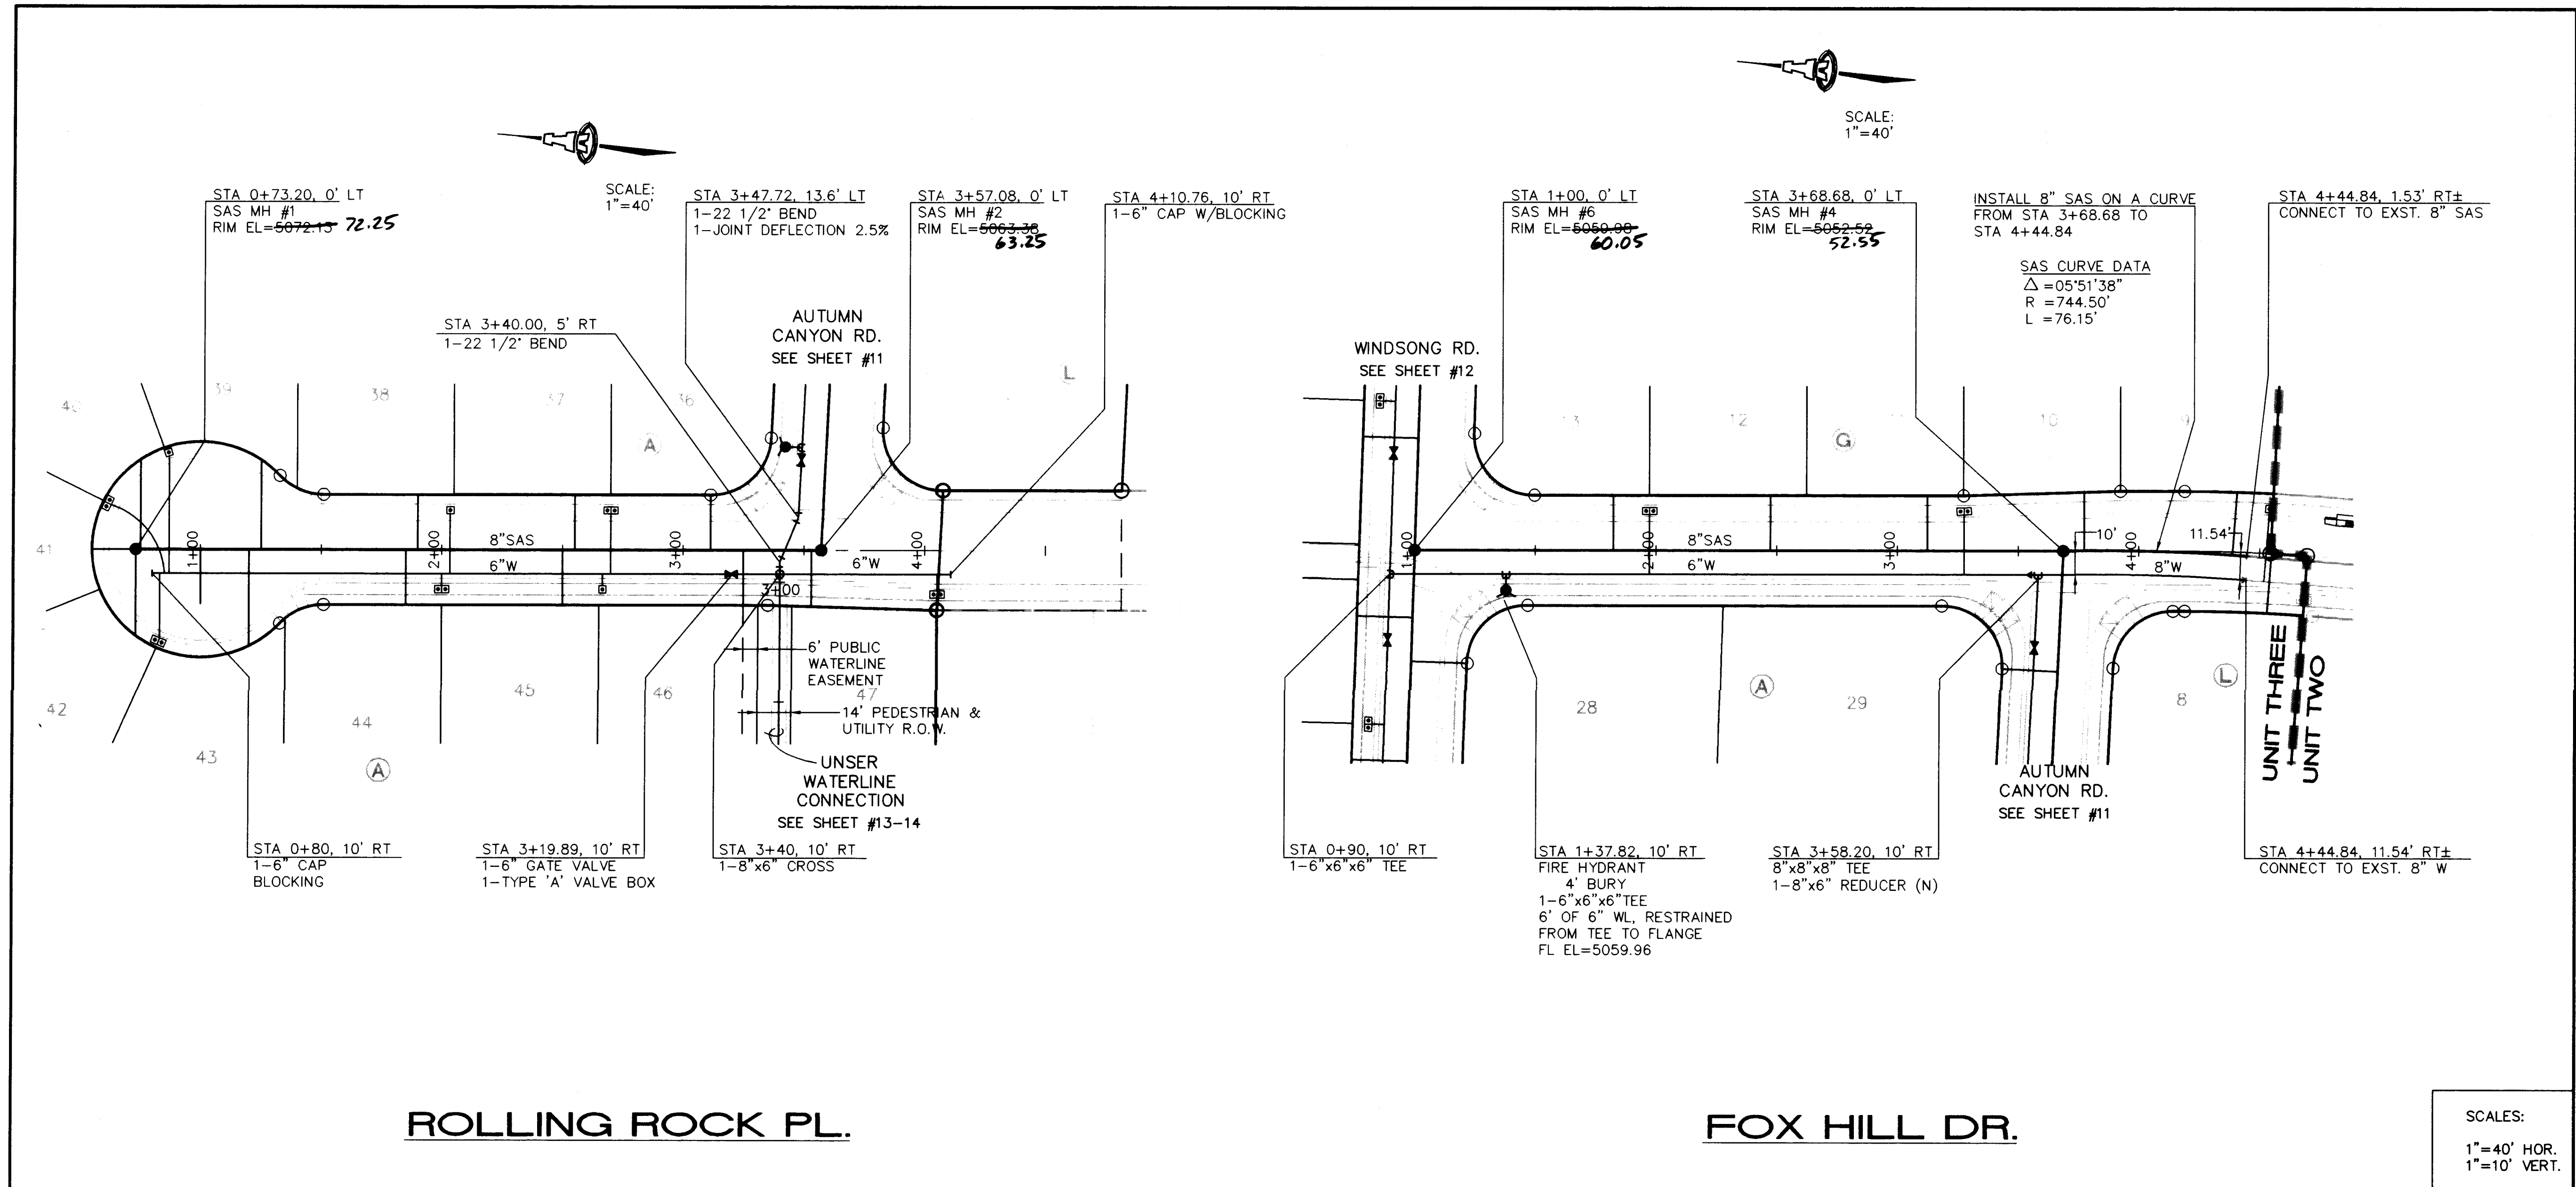


- GENERAL NOTES**
1. CONSTRUCT SAS SERVICES PER COA STD DWG #2125.
 2. CONSTRUCT ALL SINGLE & DOUBLE WATER SERVICES PER COA STD DWG'S #2361, #2362, & #2363.
 3. SEE SHEET #9 FOR WATER SHUT-OFF PLAN.
 4. SEE SHEET #9 FOR RESTRAINED JOINT LENGTHS FOR WATER LINE FITTINGS.
 5. CONSTRUCT FIRE HYDRANTS PER DESIGNATED DEPTHS & LENGTHS PER COA STD DWG #2340.

SAS SERVICE TABLE

LOT NO.	STA.	INV. @ R/W
BLOCK (A)		
36	3+11	59.8
37	2+55	61.4
38	1+90	63.4
39	1+25	65.5
40	0+72	67.2
41	SAS MH	67.7
42	0+69	67.2
43	1+20	65.6
44	1+55	63.6
45	2+50	61.6
46	3+25	59.4
47	3+53	58.5
BLOCK (C)		
9	4+40	45.9
10	3+77	47.6
11	3+12	49.2
12	2+47	51.2
13	1+82	53.2

WL SERVICE TABLE

LOT NO.	STA.	TYPE	LENGTH
BLOCK (A)			
36			26'
37	2+69.99	DS	26'
38	2+04.99	SS	26'
39	0+87.14	SS	49'
40	AT PROJECTED LOT LINE 40/41	DS	40'
41			40'
42	0+83.20	DS	29'
43			29'
44			7'
45	2+00.00	DS	7'
46	3+35.00	SS	7'
47	4+05.15	DS	7'
BLOCK (C)			
9	4+53.11	SS	30'
10	3+27.36	DS	26'
11			26'
12	1+97.36	DS	26'
13			26'

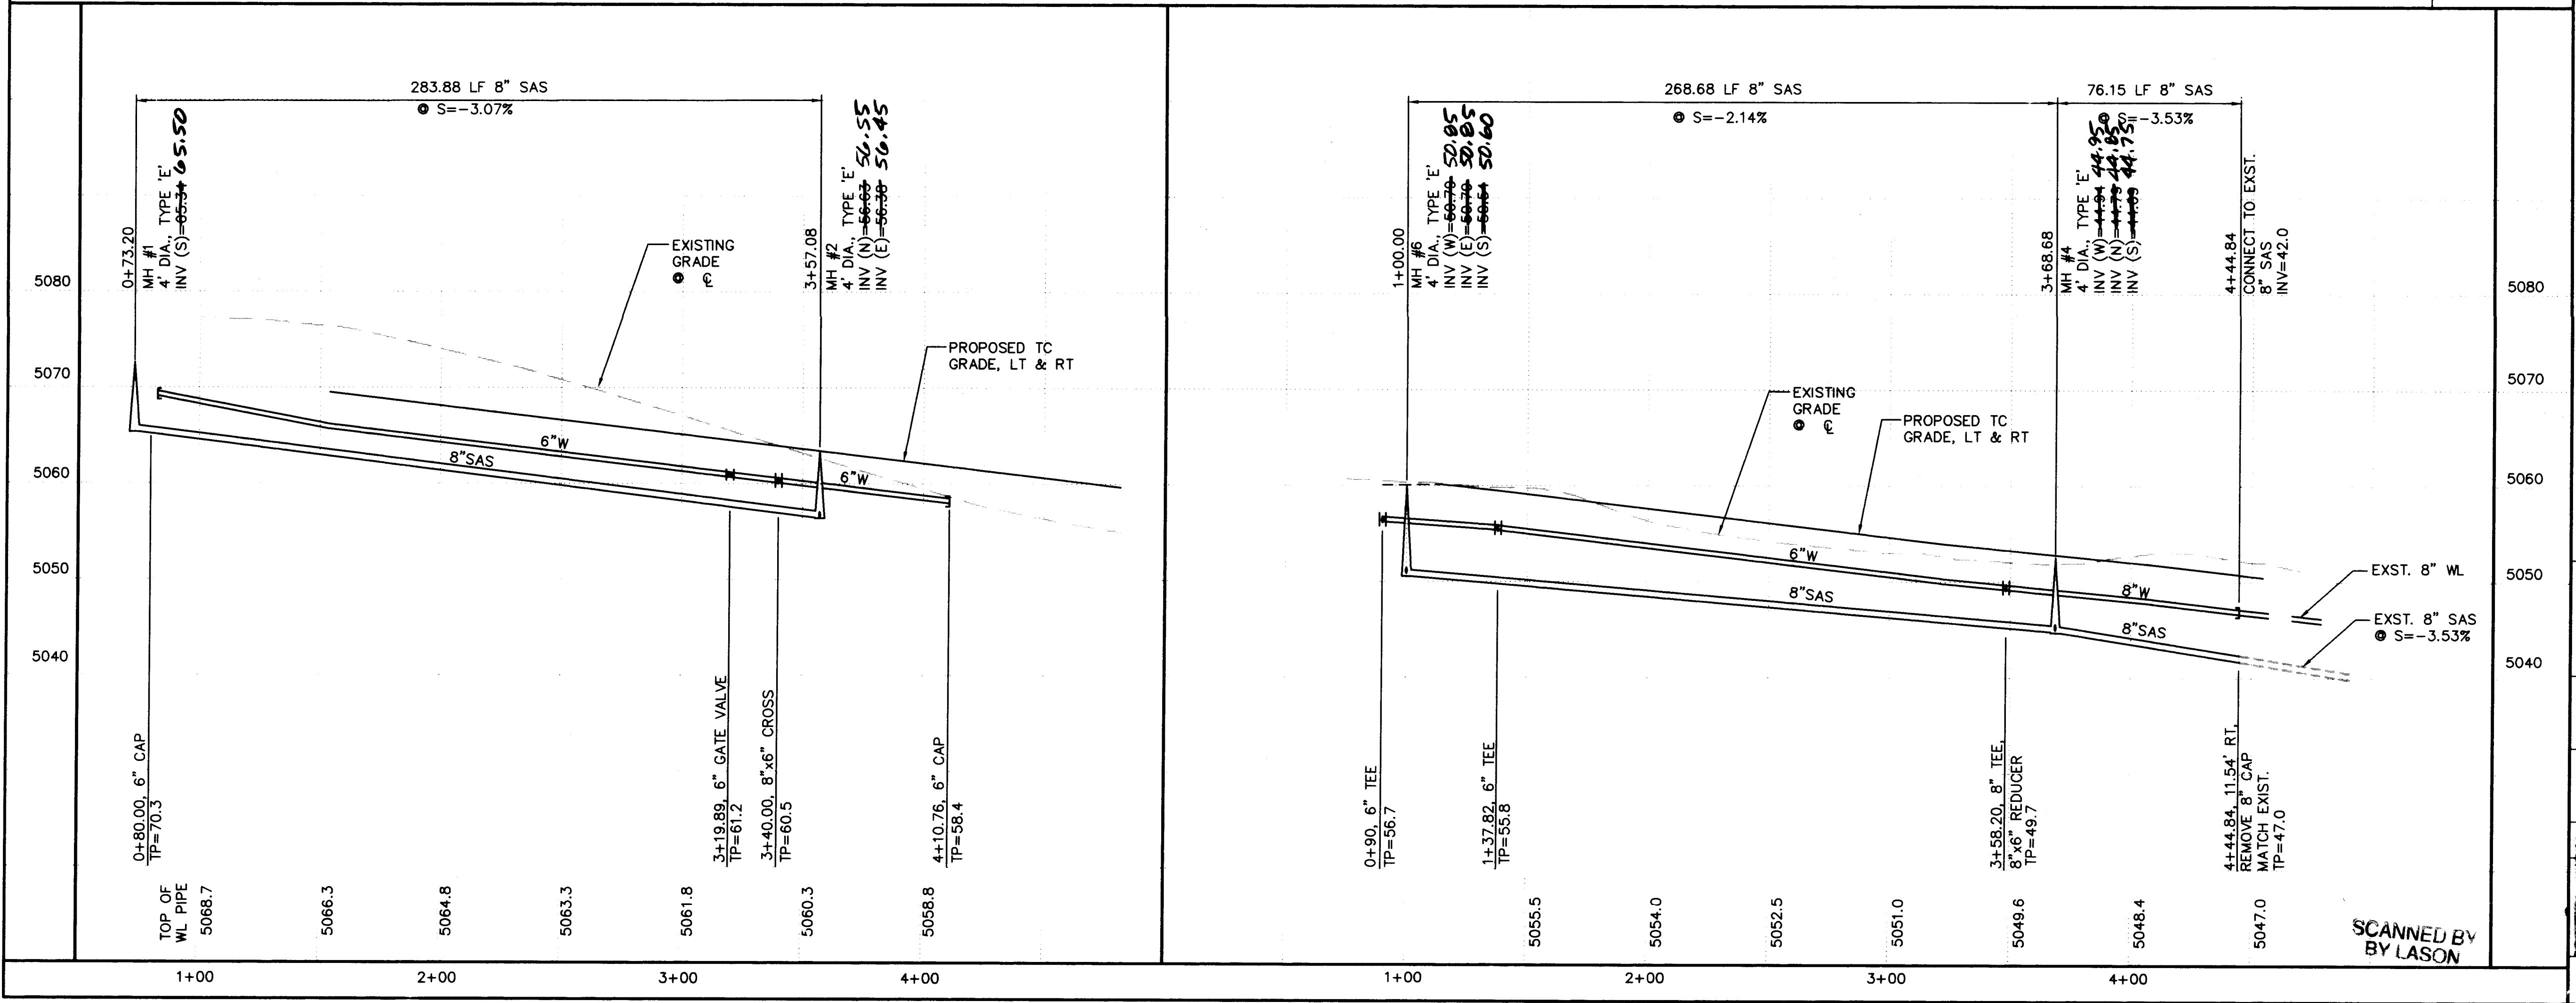



ISAACSON & ARFMAN, P.A.
Consulting Engineering Associates
128 Monroe Street N.E.
Albuquerque, New Mexico 87102
917UTL1.DWGonw 05/06/97


CITY OF ALBUQUERQUE
PUBLIC WORKS DEPARTMENT
ENGINEERING GROUP

TITLE: **ROLLING HILLS SUBDIVISION--UNIT 3
ROLLING ROCK PL. & FOX HILL DR.
UTILITY PLAN & PROFILE**


Design Review Committee	City Engineer Approval	Mo./Day/Yr.	Mo./Day/Yr.

City Project No. **5379.92** Zone Map No. **M-10** Sheet **10** Of **14**

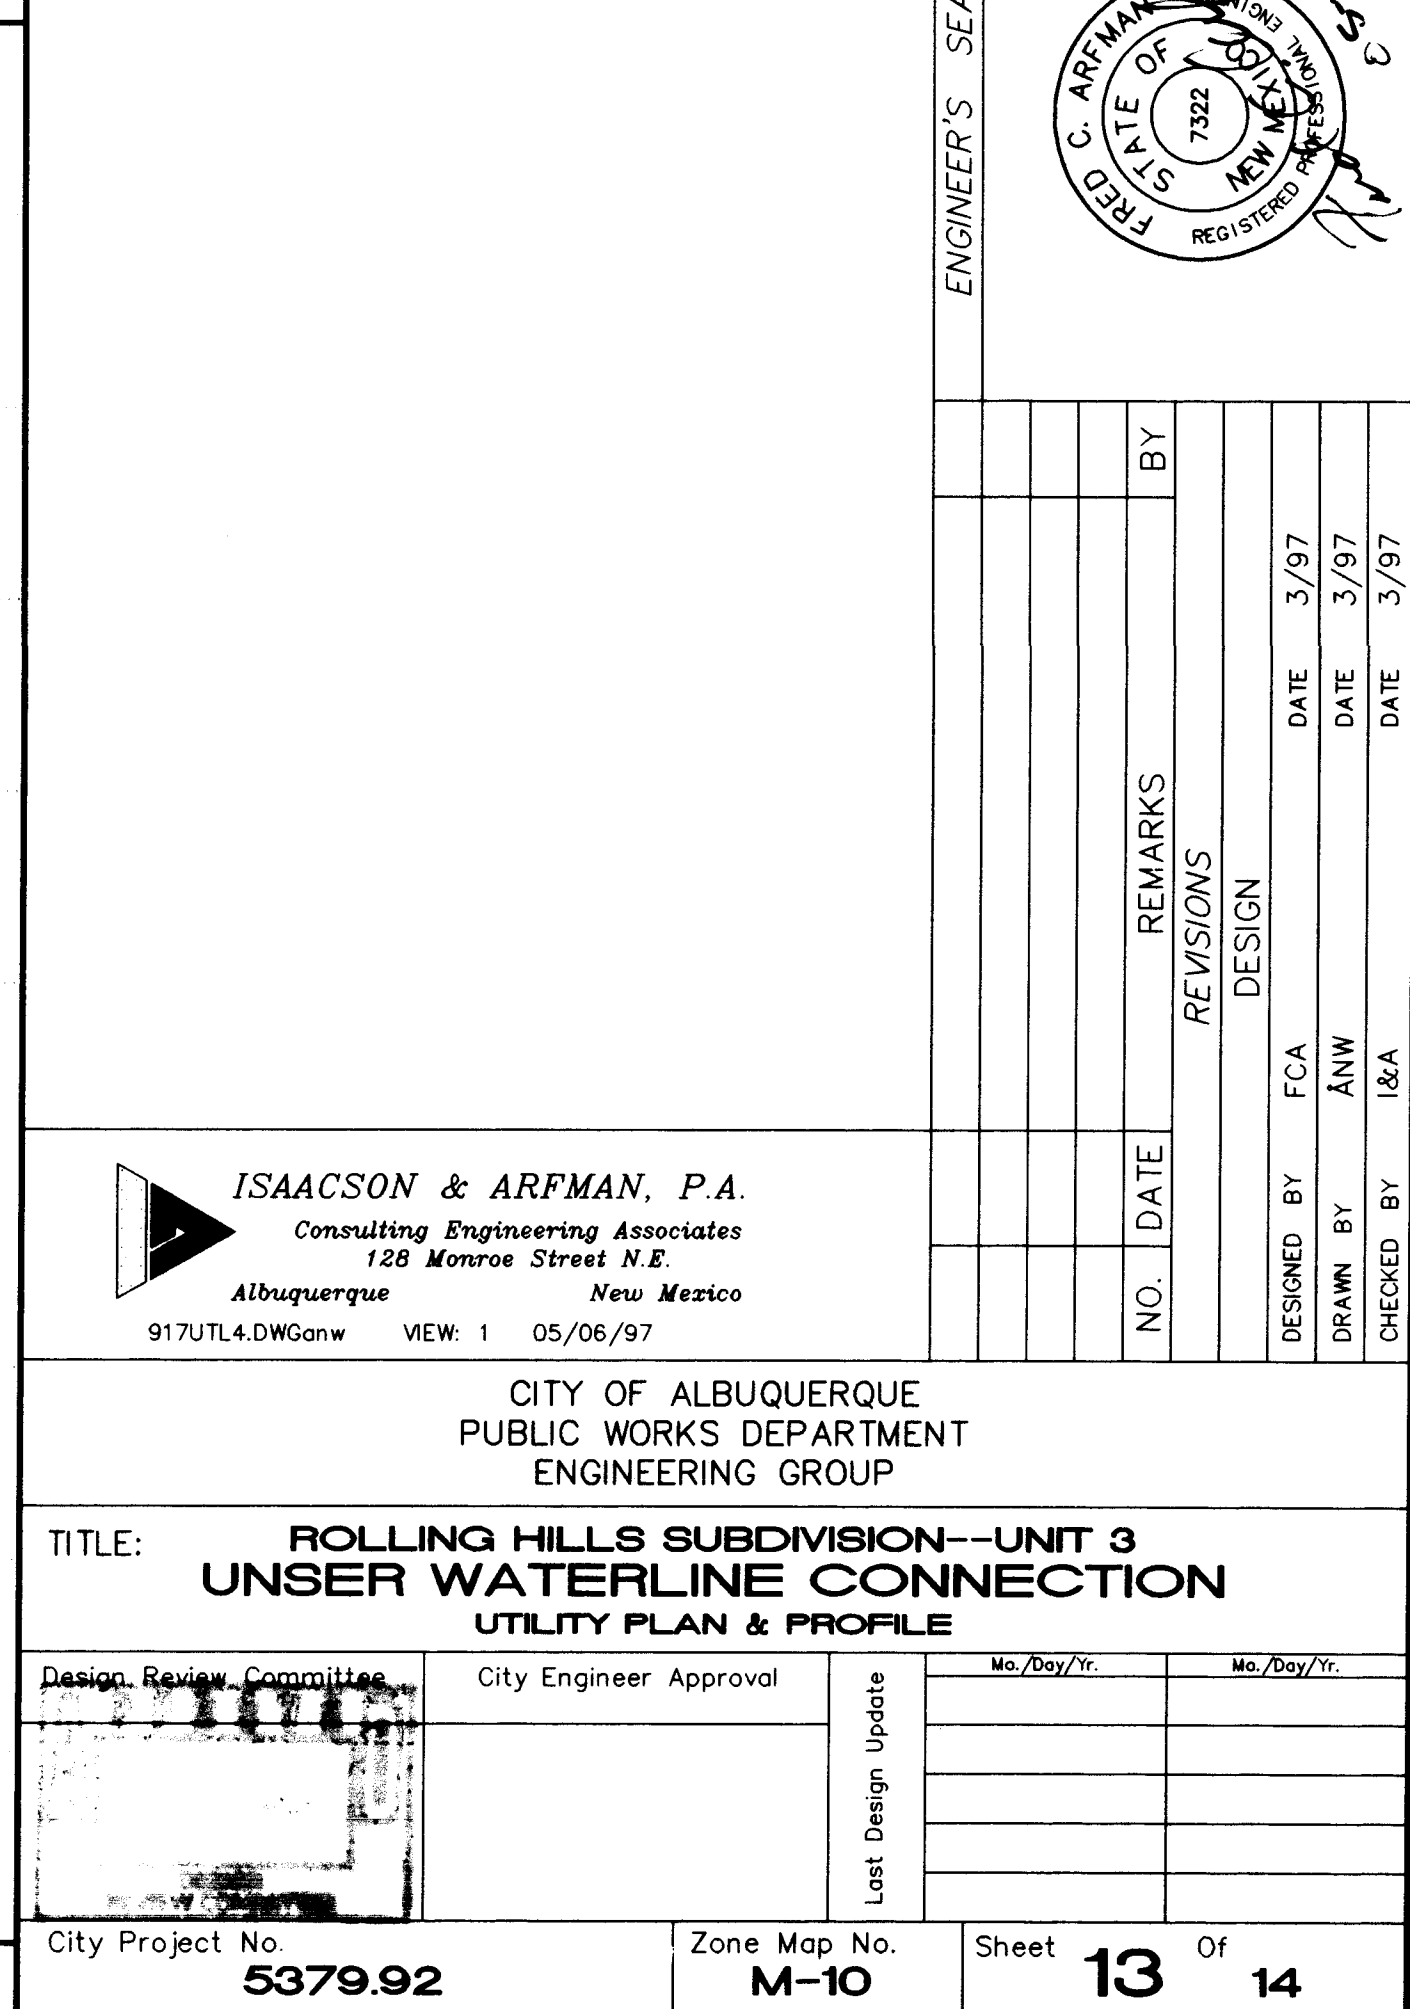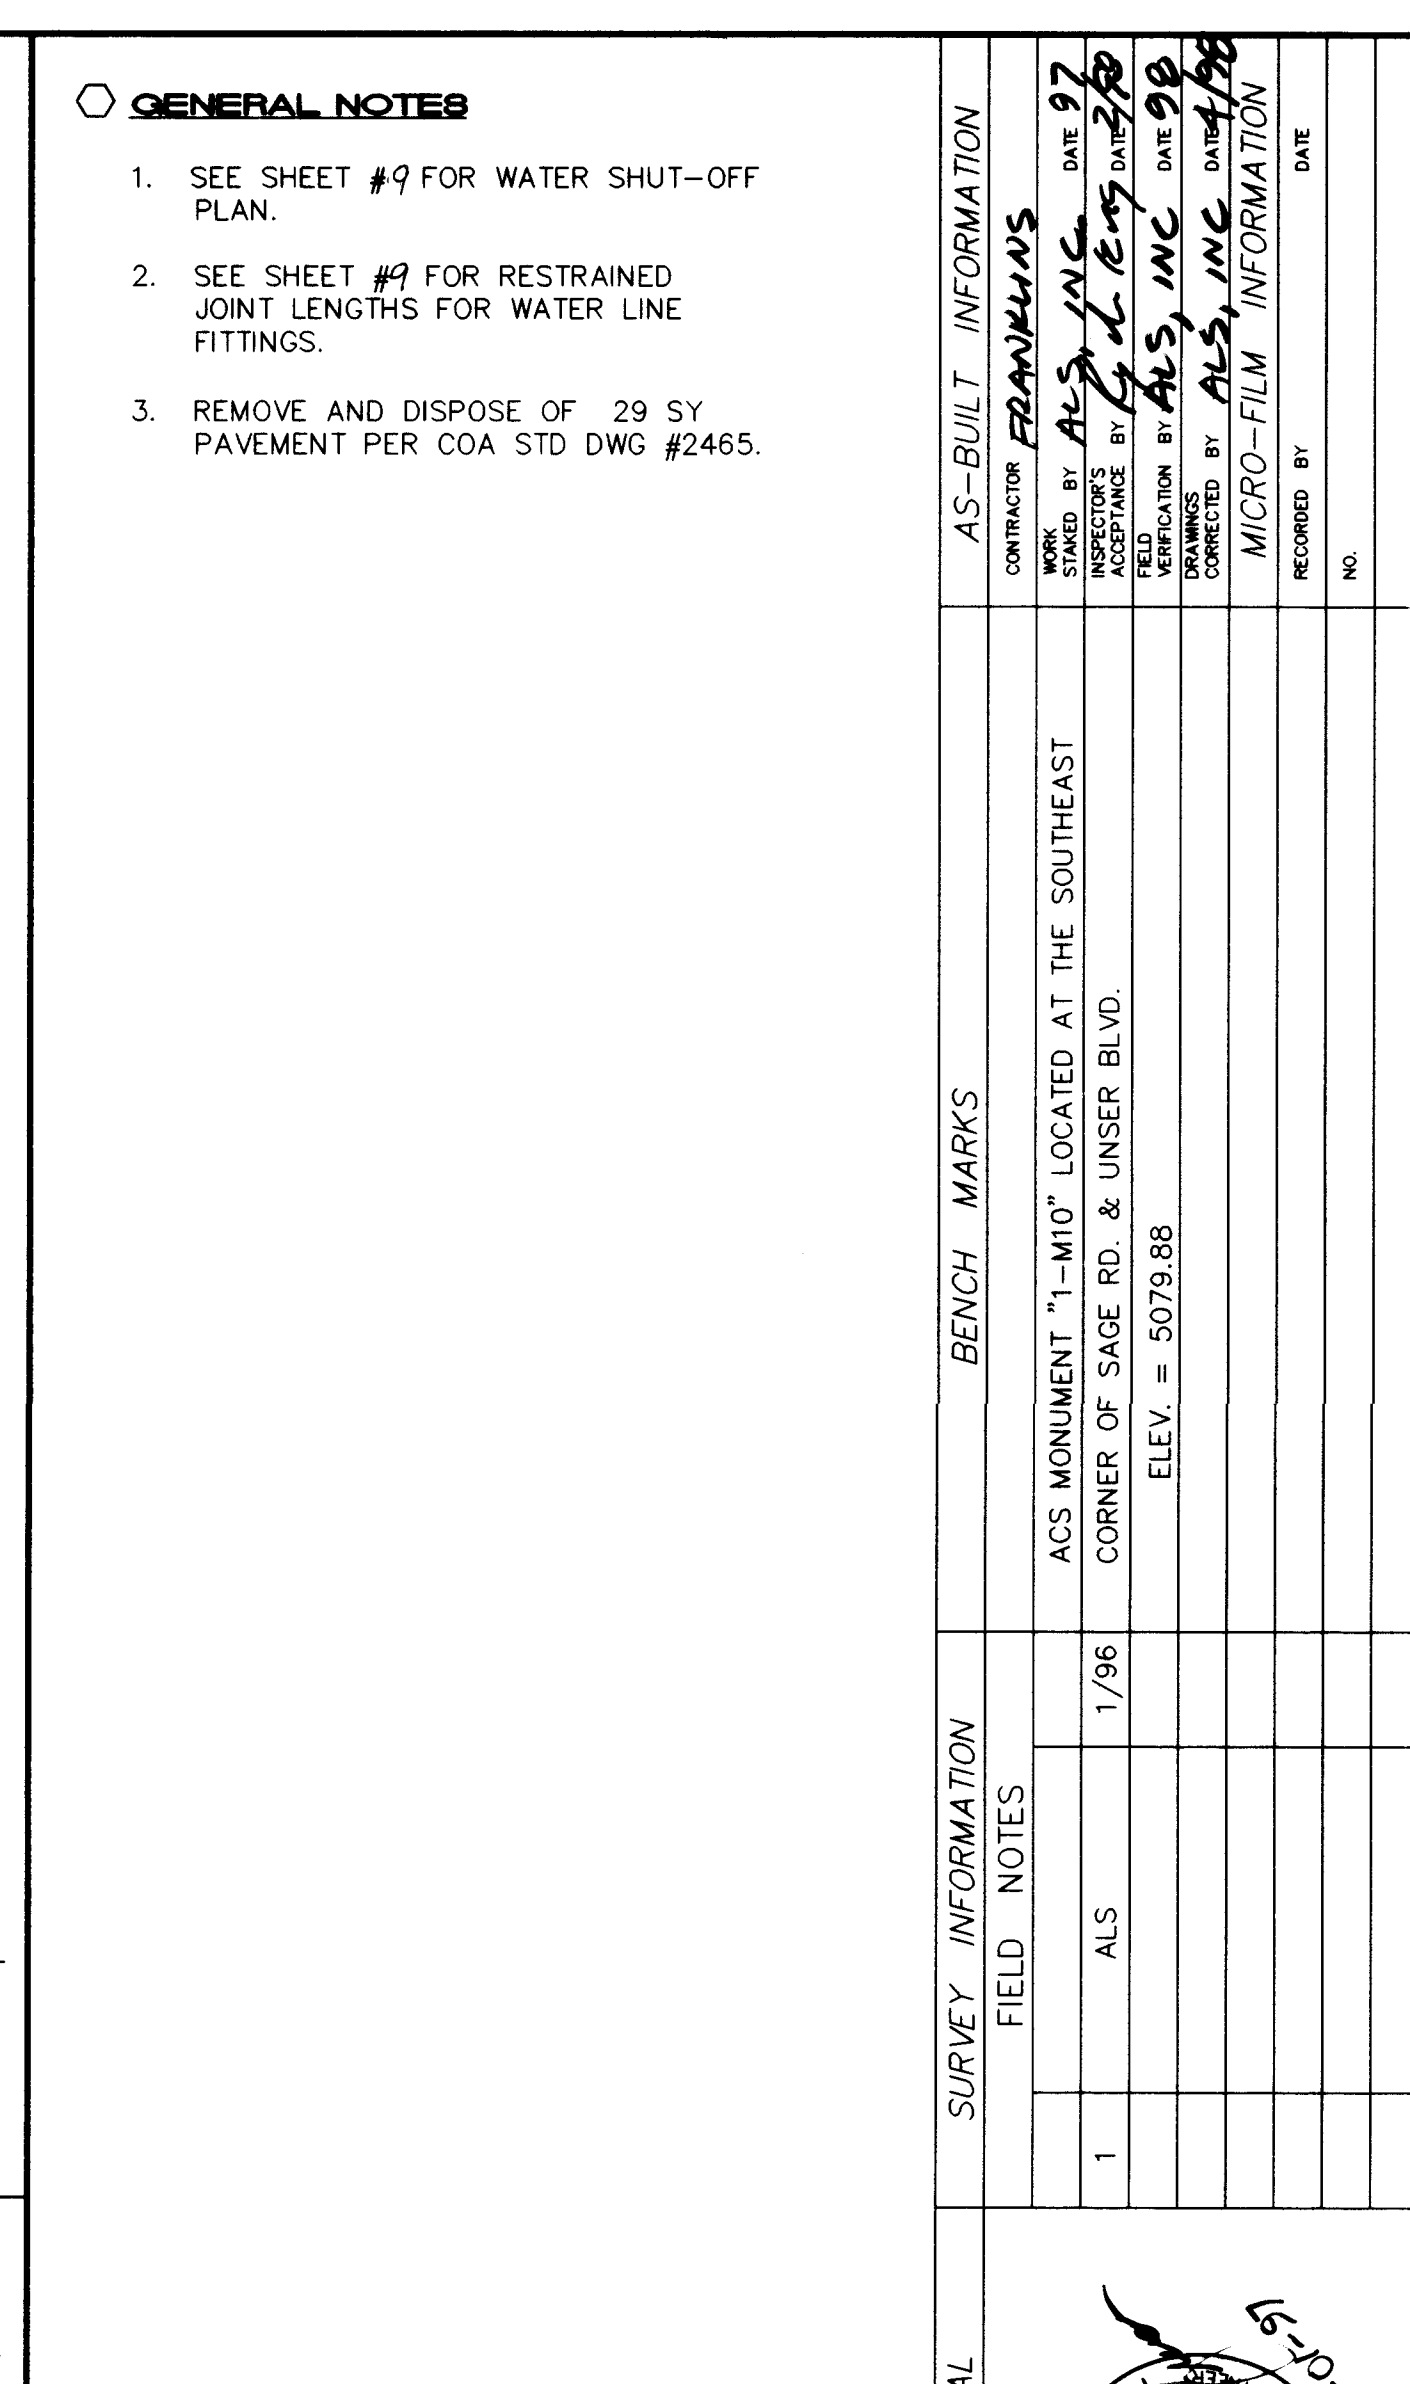


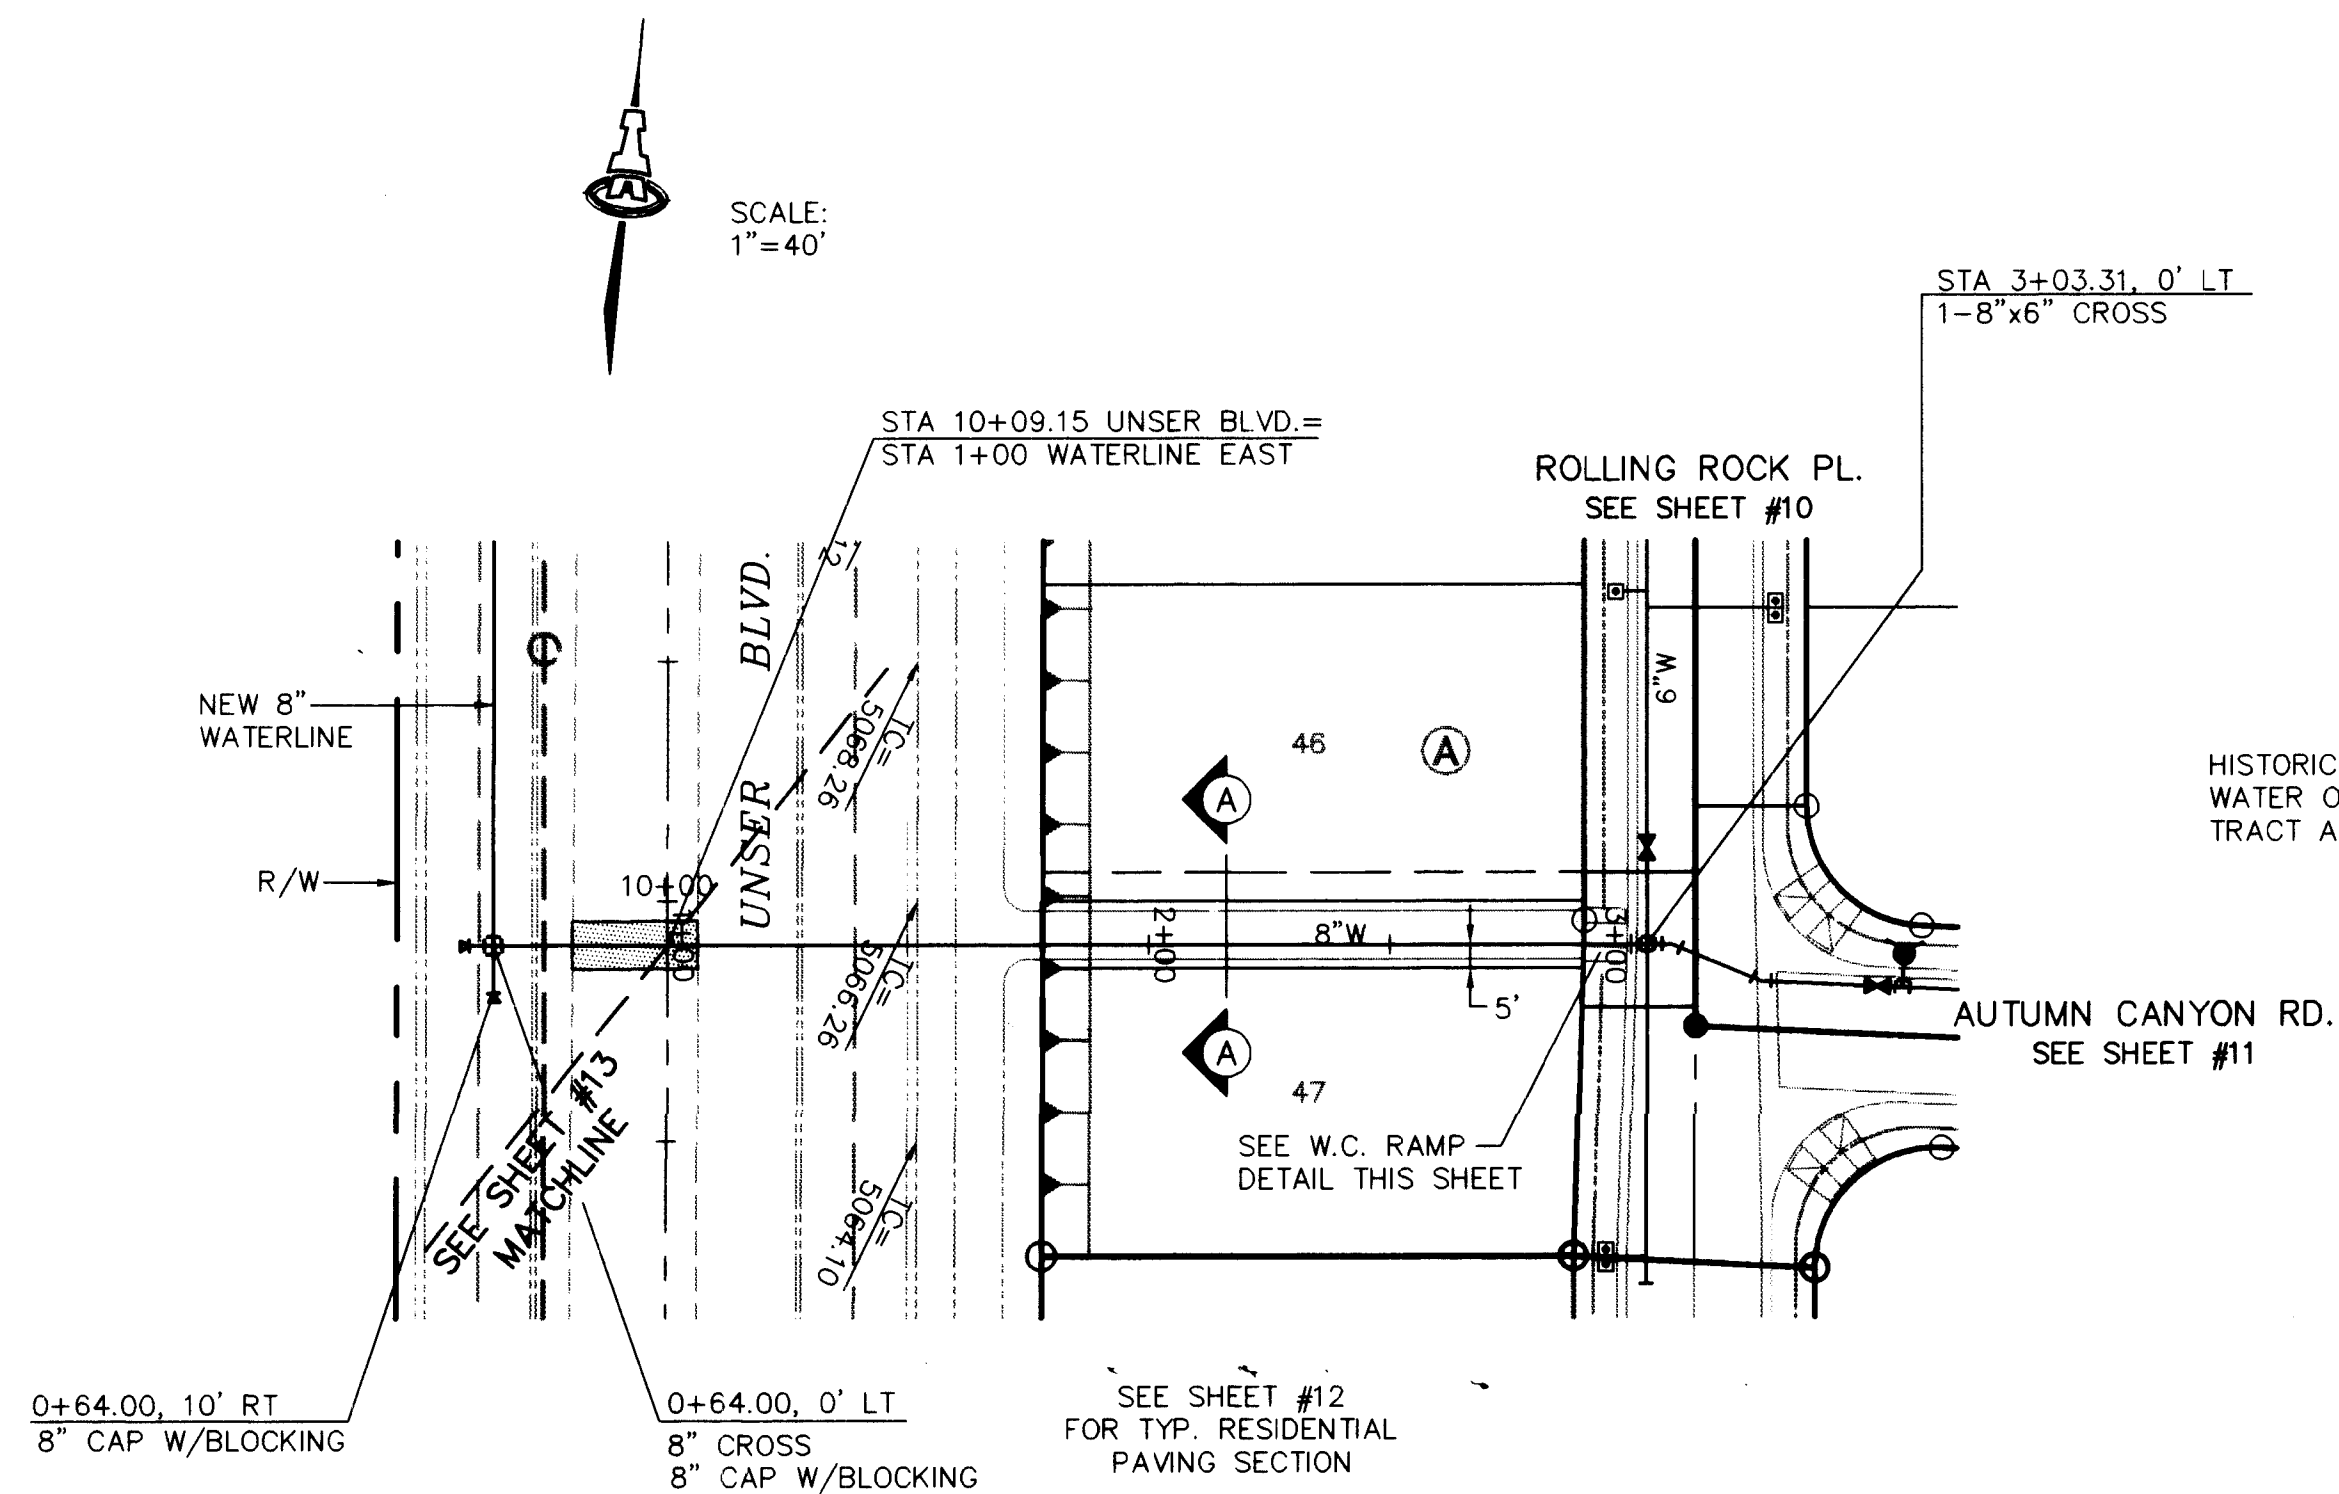

UNSER WATERLINE CONNECTION

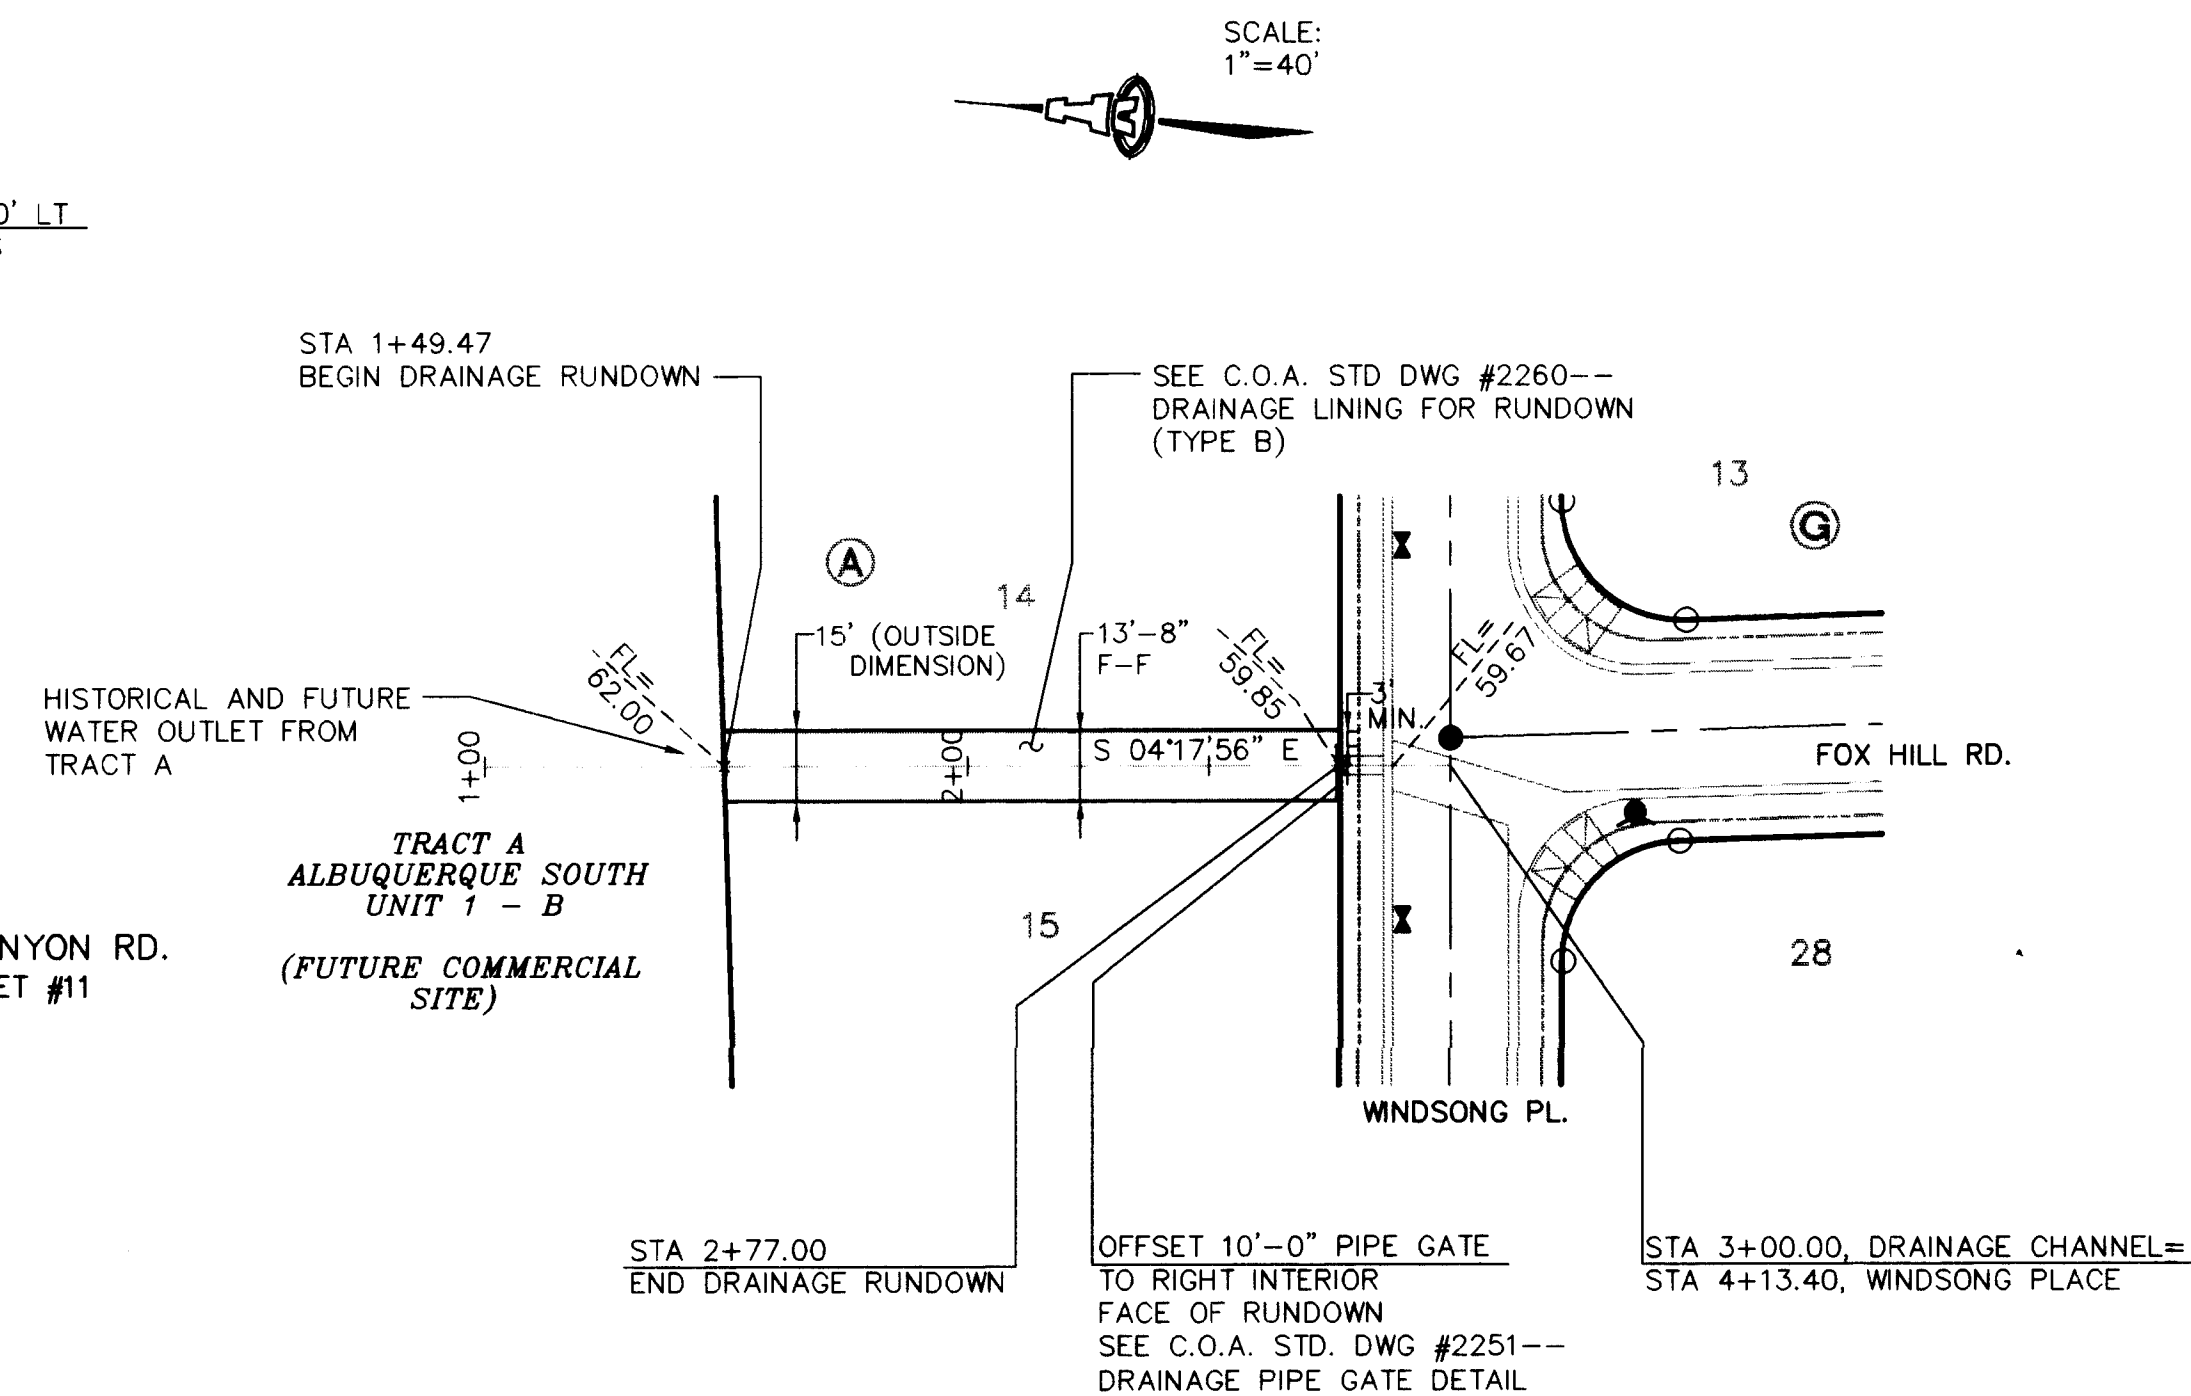


DRAINAGE RUNDOWN

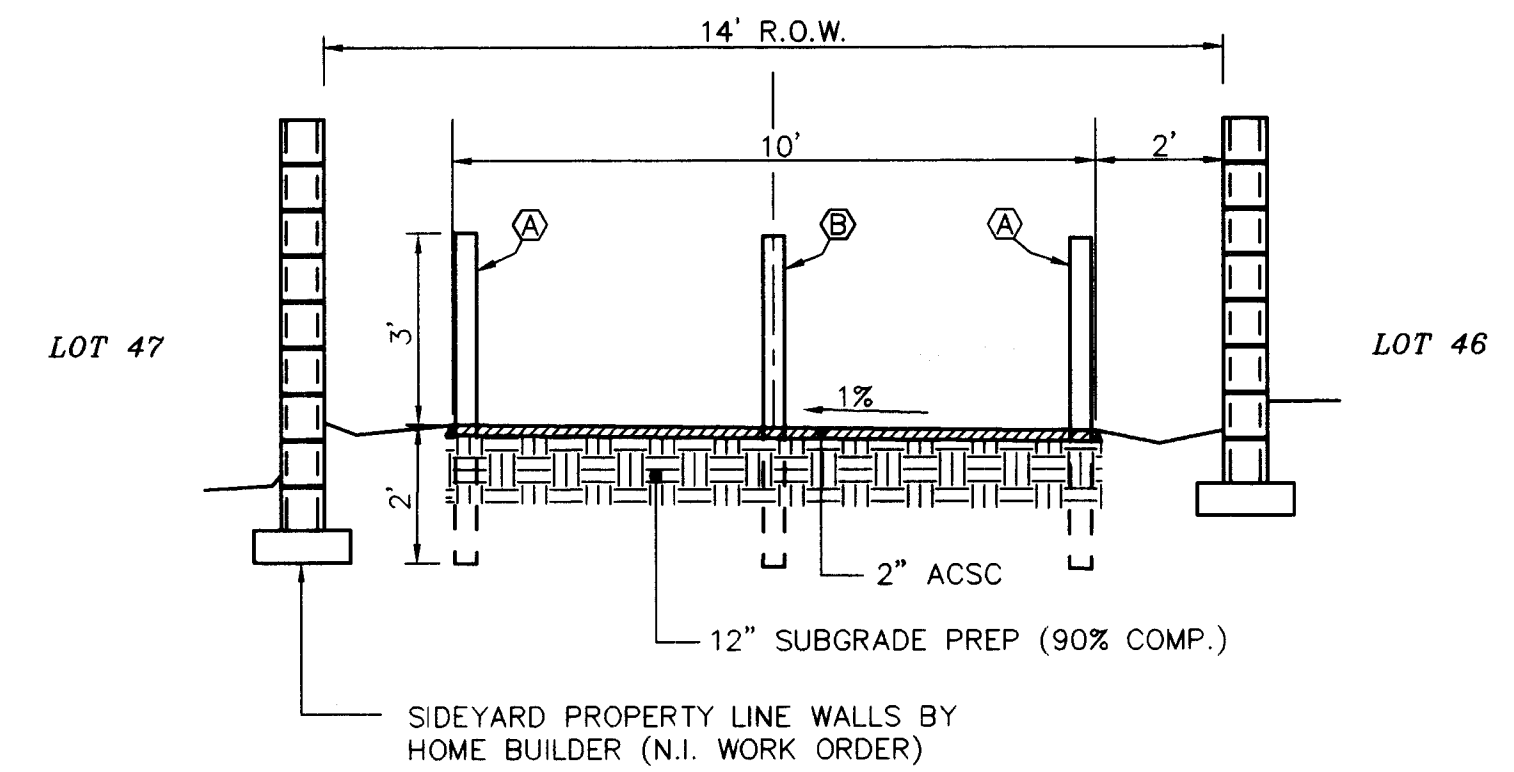

SECTION A-A
PEDESTRIAN TRAIL
PAVING SECTION
1"=3'-0" (H. & V.)

BOLLARD SCHEDULE

- A. 4" STEEL PIPE BOLLARD, PCC FILLED
B. 4" STEEL PIPE BOLLARD, REMOVABLE PER C.O.A. DWG 2250.


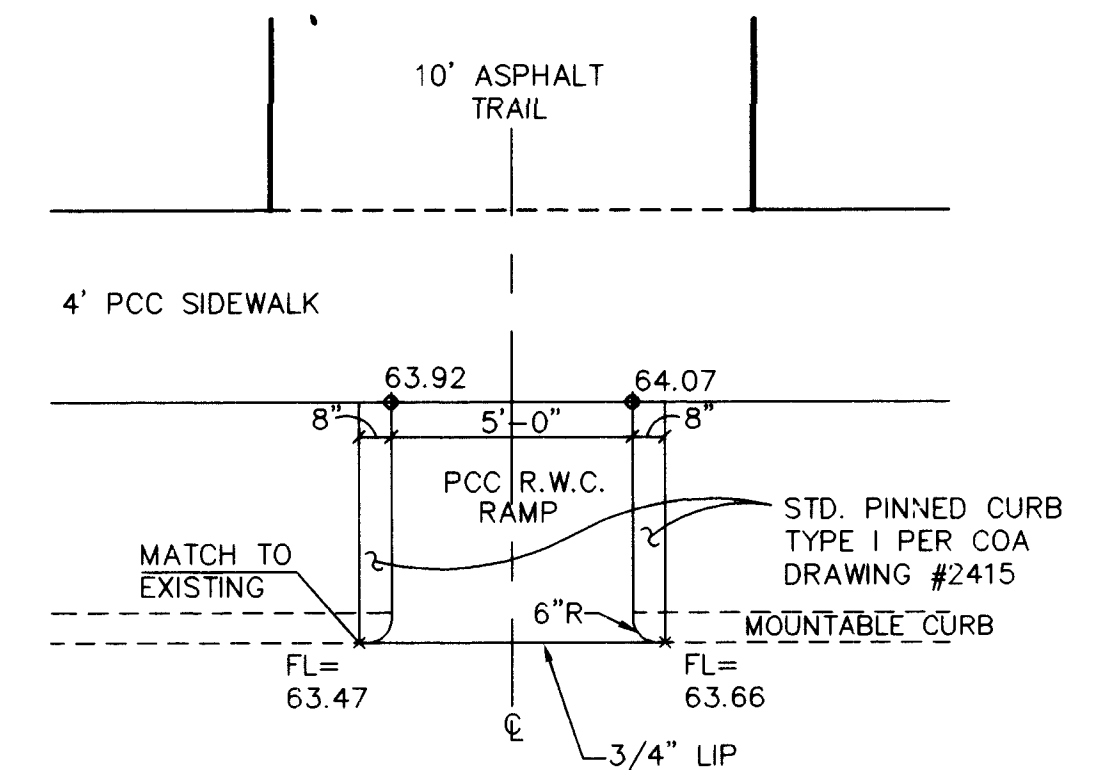


TRAIL R.W.C. RAMP
1"=4'

SCALES:
1"=40' HOR.
1"=10' VERT.

GENERAL NOTES

1. SEE SHEET #9 FOR WATER SHUT-OFF PLAN.
2. SEE SHEET #9 FOR RESTRAINED JOINT LENGTHS FOR WATER LINE FITTINGS.

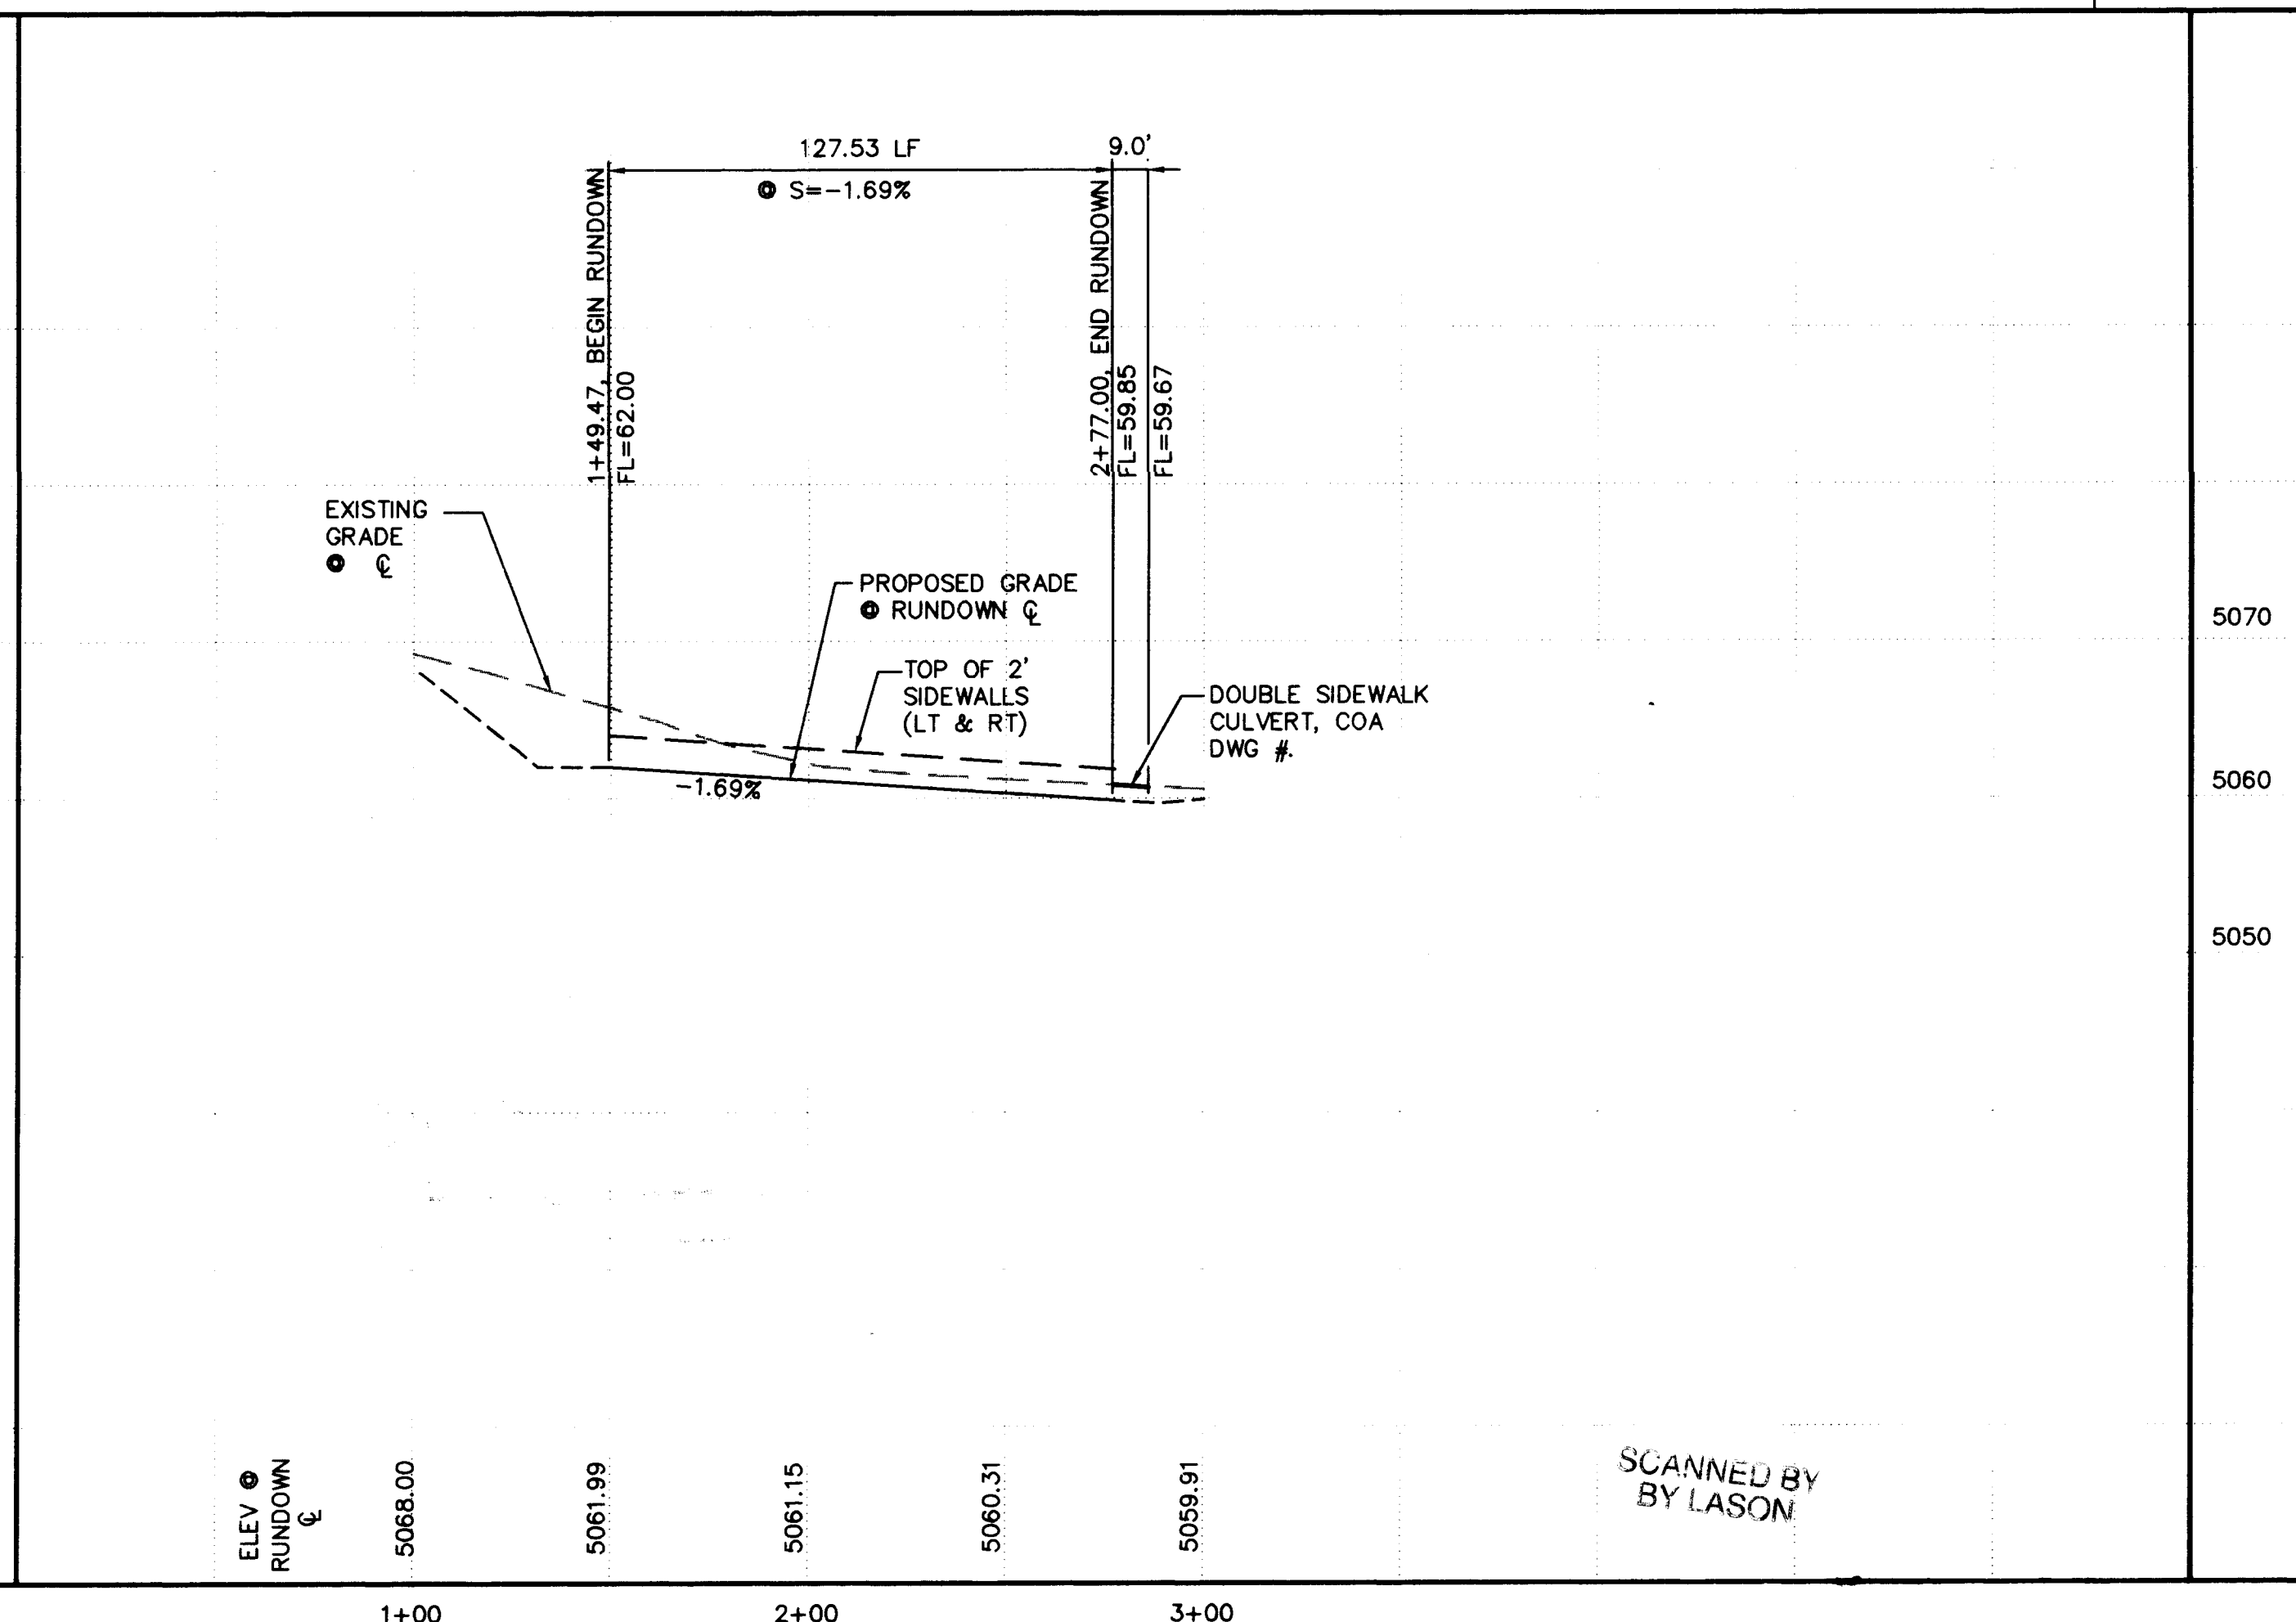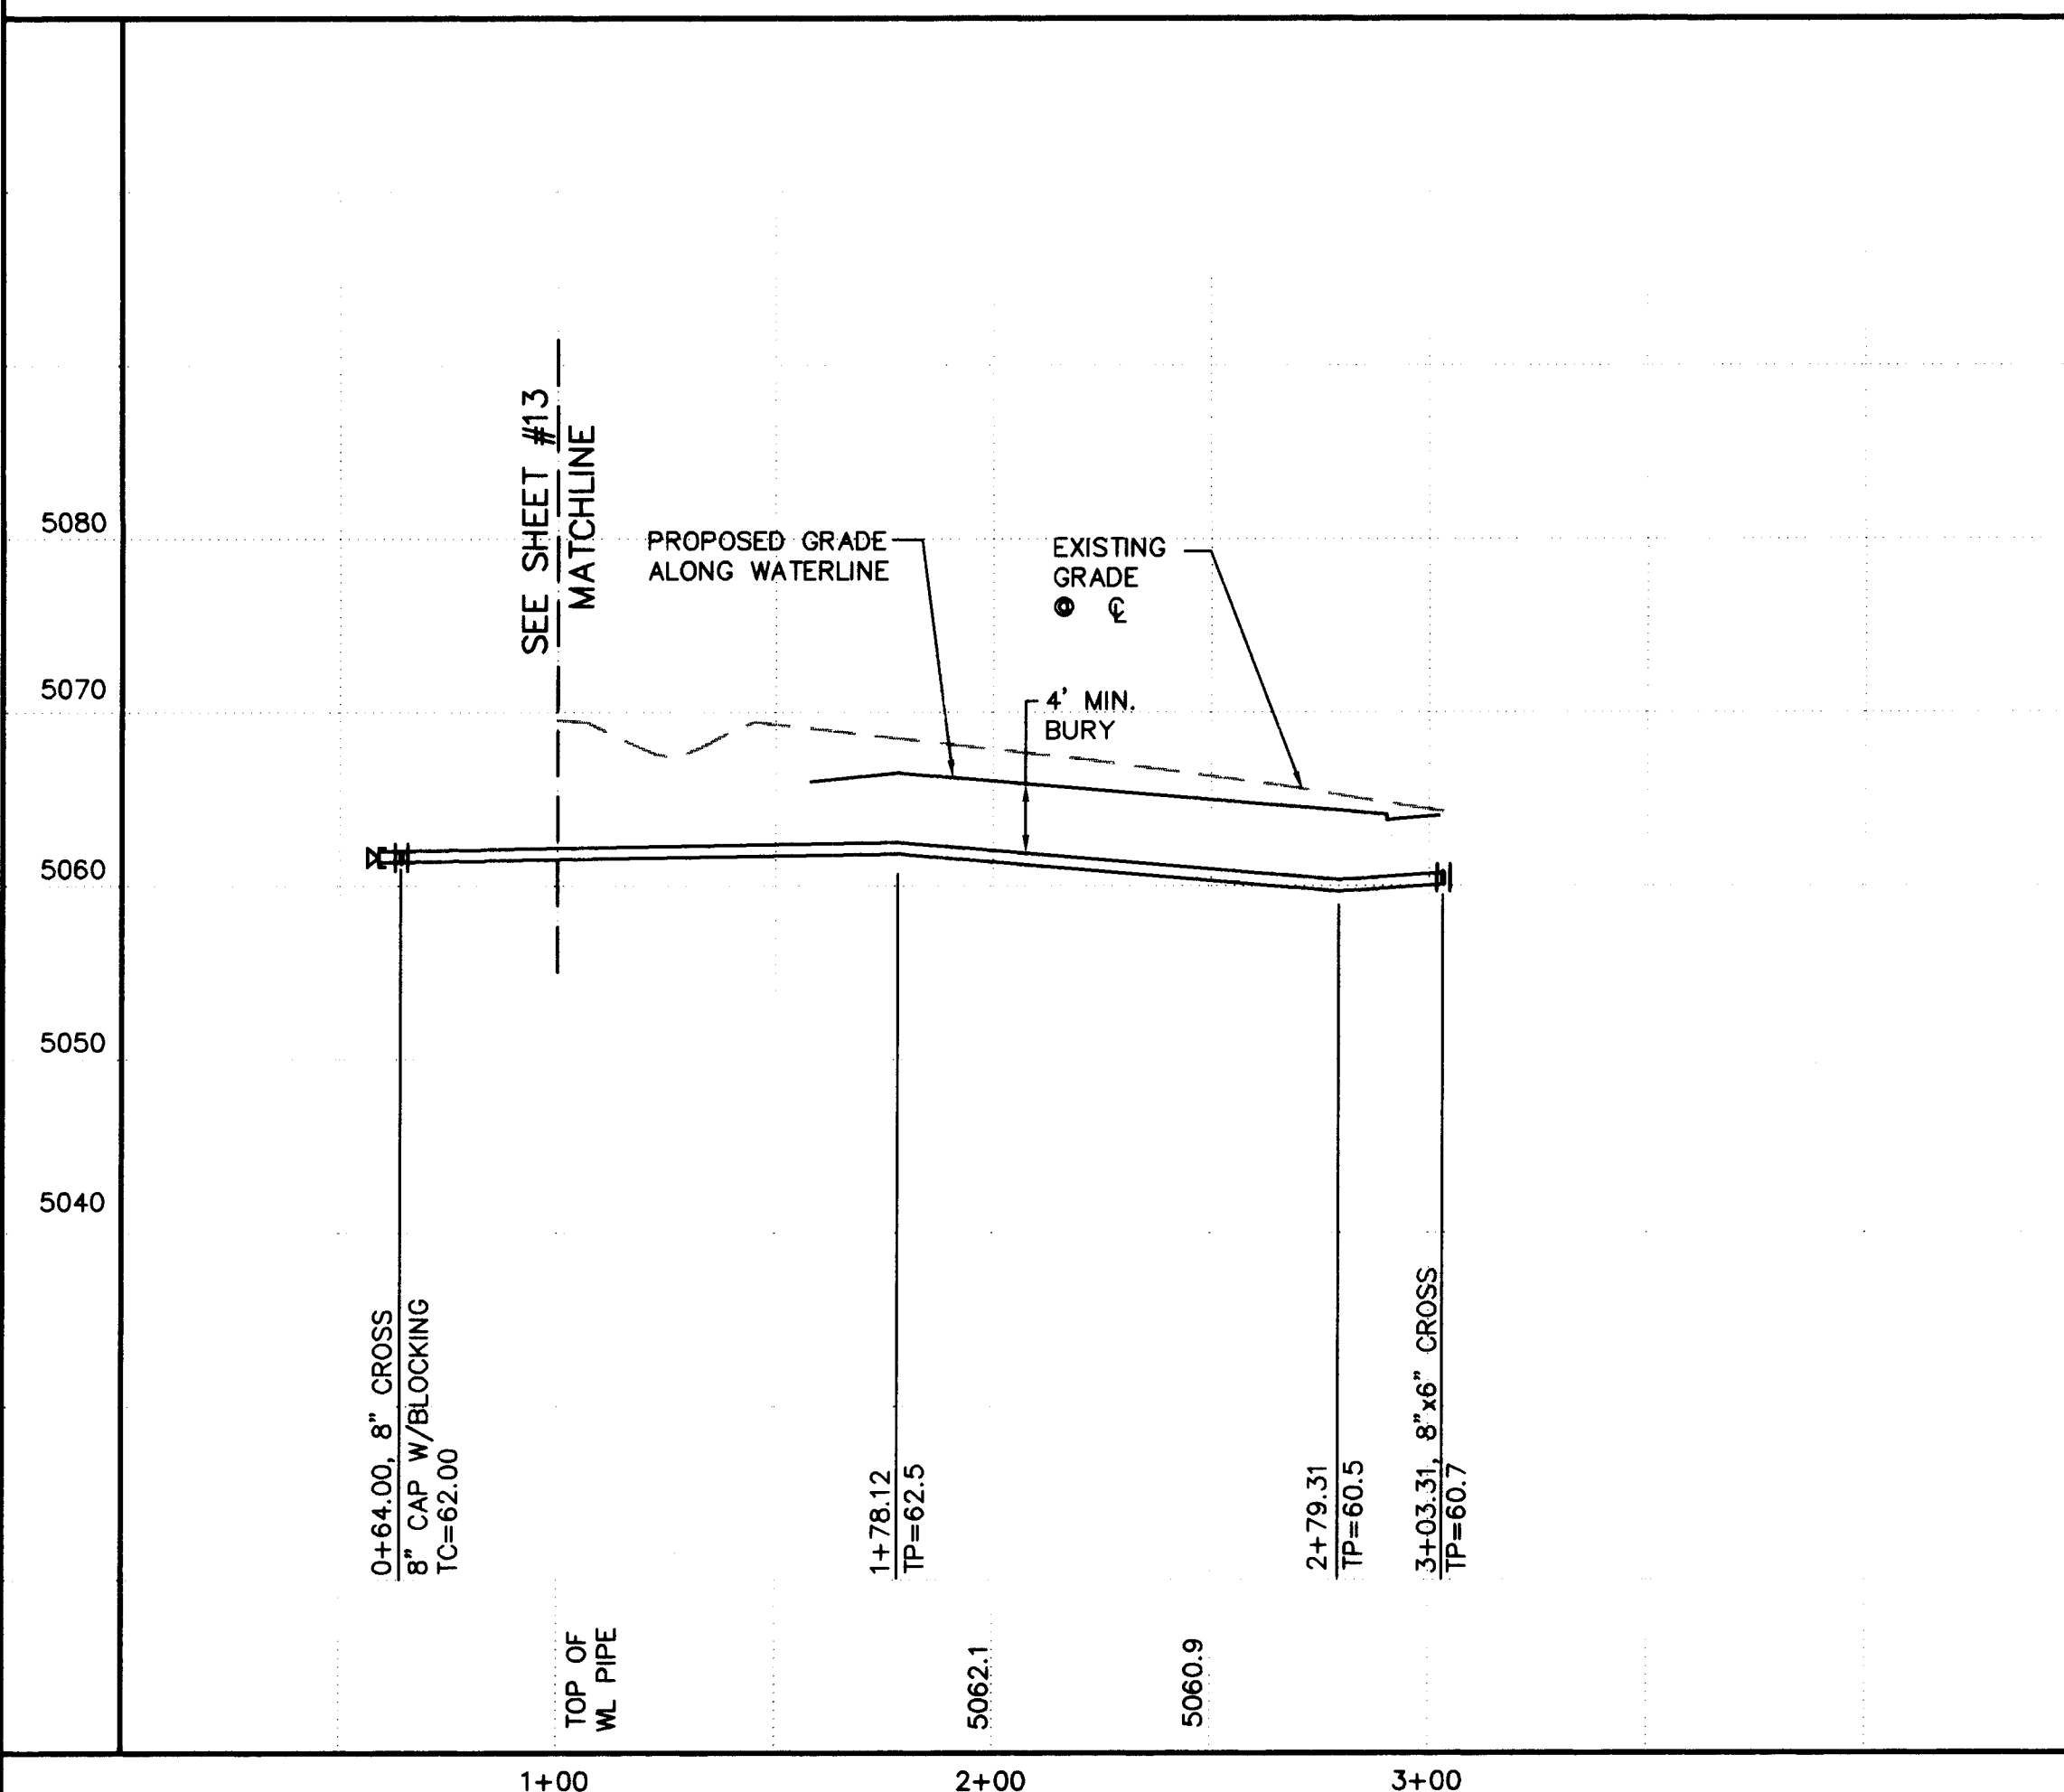

SCANNED BY
BY LASON

ISAACSON & ARFMAN, P.A.
Consulting Engineering Associates
128 Monroe Street N.E.
Albuquerque New Mexico
917UTL4.DWGonw VIEW: 2 05/19/97

CITY OF ALBUQUERQUE
PUBLIC WORKS DEPARTMENT
ENGINEERING GROUP

TITLE: ROLLING HILLS SUBDMISION--UNIT 3
UNSER WATERLINE CONNECTION
& DRAINAGE RUNDOWN




City Engineer Approval

Last Design Update

City Project No. 5379.92

Zone Map No. M-10

Sheet 14 Of 14

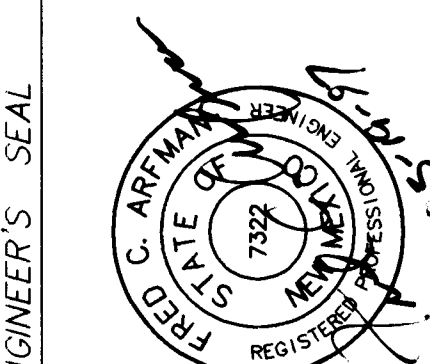

AS-BUILT INFORMATION		BENCH MARKS		SURVEY INFORMATION		ENGINEER'S SEAL	
CONTRACTOR	WORK	DATE	NO.	FIELD NOTES	NO.	NO.	DATE
FRANKLIN'S	AS-BUILT	05/97		ACS MONUMENT "1-M10" LOCATED AT THE SOUTHEAST CORNER OF SAGE RD. & UNSER BLVD. ELEV. = 5079.88	1		
BY: AS, INC.	DATE: 05/97						
CHECKED BY: AS, INC.	DATE: 05/97						
RECORDED BY: AS, INC.	DATE: 05/97						
MICRO-FILM INFORMATION							
NO.	DATE						