

BERNALILLO COUNTY OF NEW MEXICO

PUBLIC WORKS DEPARTMENT


UTILITIES DIVISION

CONSTRUCTION PLANS

FOR

COORS PARK & DESERT PALMS SEWER PROJECT

SCANNED BY
MESA REPRO

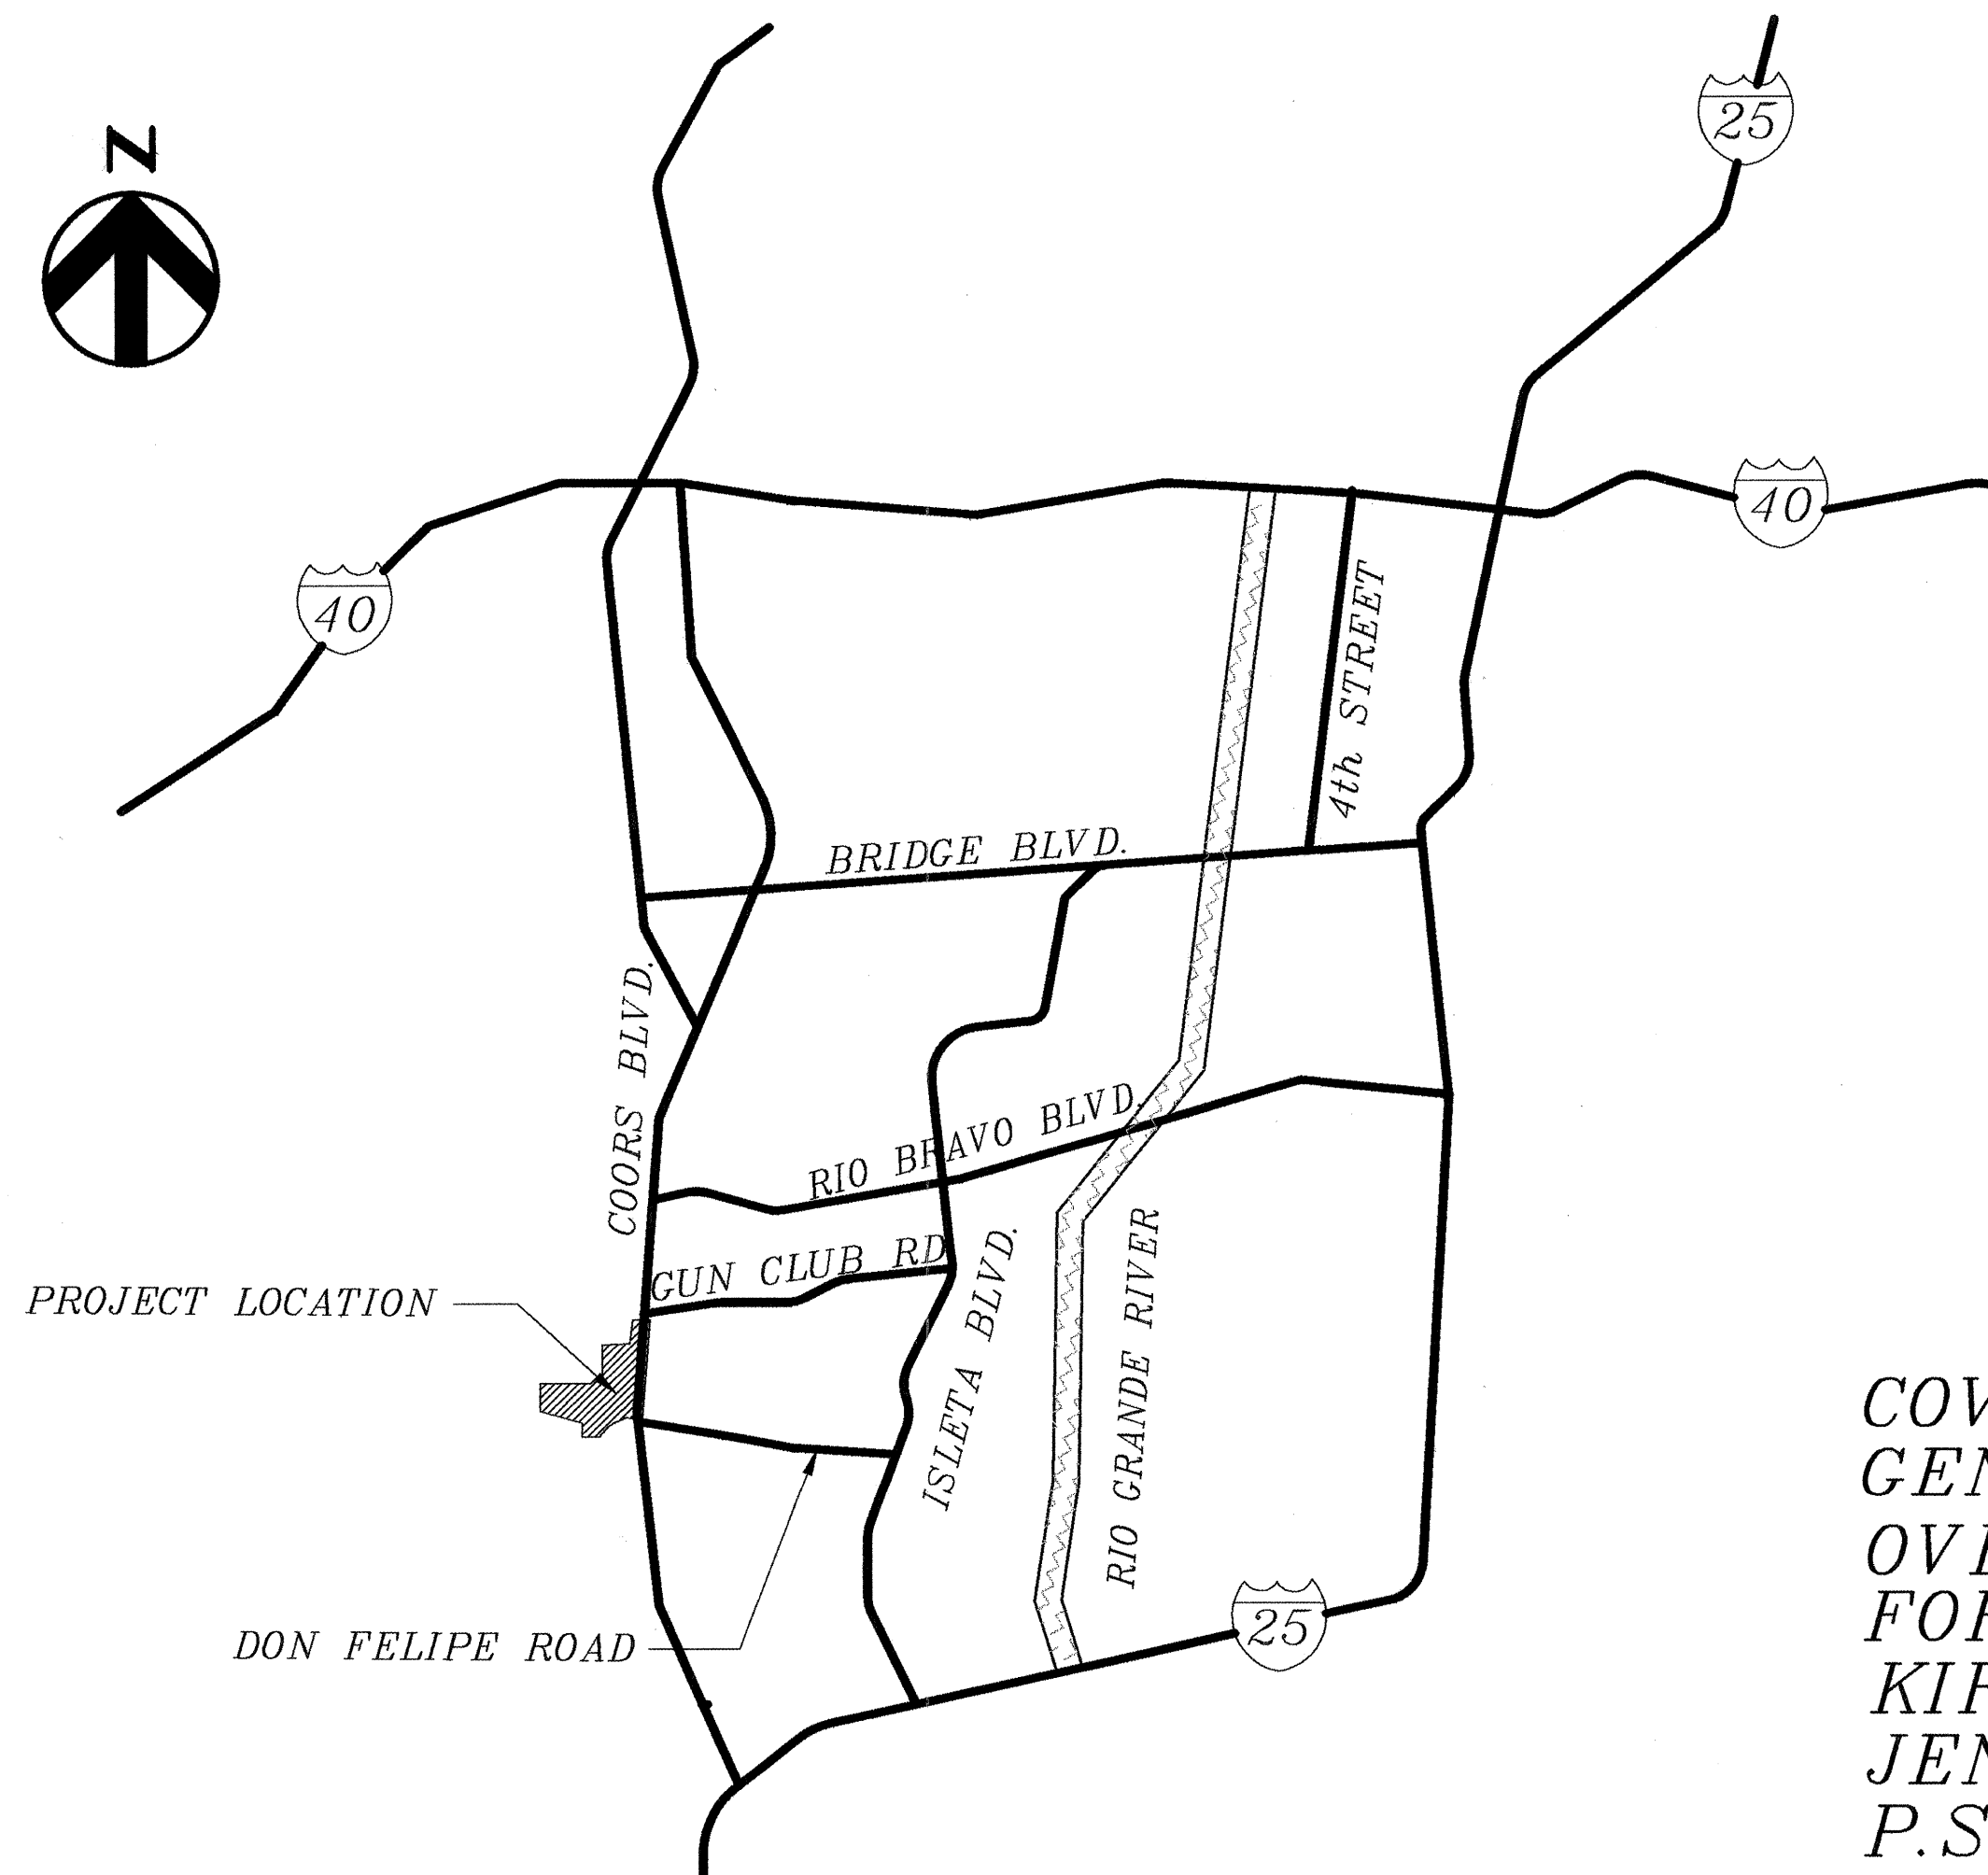

APPROVAL OF AS BUILT DRAWINGS
CHIEF CONSTRUCTION ENGINEER
August 11, 2000
DATE 1-24-00

BERNALILLO
COUNTY
PUBLIC WORKS



STATE
OF
NEW MEXICO

"AS RECORDED"
From information
provided by the
contractors
By *[Signature]* Date 12/4/98

SHEET INDEX

COVER	1
GEN. NOTES/MISC. DETAILS	2
OVERALL PROJECT SITE	3
FORCEMAIN	4-6
KIRSTEN RD.	7-8
JENNIE RD.	9-10
P.S./FM DETAILS	11-16

HDR
HDR Engineering, Inc.
6200 Uptown Boulevard N.E., Suite 220
Albuquerque, NM 87110-4142
(505) 884-6065; FAX: (505) 884-5969

REV.	SHEETS	CITY ENGINEER	DATE	USER DEPARTMENT	DATE	USER DEPARTMENT	DATE		
ENGINEER'S STAMP & SIGNATURE		APPROVALS		ENGINEER		DATE		*****	
 07/30/98		DRC Chairman						APPROVED FOR CONSTRUCTION	
		Transportation						7-30-98	
		Water/Wastewater		August 11, 2000		8-1-98		County Engineer DATE	
		Hydrology							
		Parks							
		Construction Management							
		City Project No.		5737.90		Sheet 1 Of 16			


GENERAL NOTES:

- ALL WORK DETAILED ON THESE PLANS TO BE PERFORMED UNDER THIS CONTRACT SHALL, EXCEPT AS OTHERWISE STATED OR PROVIDED FOR HEREON, BE CONSTRUCTED IN ACCORDANCE WITH THE CITY OF ALBUQUERQUE STANDARD SPECIFICATIONS FOR PUBLIC WORKS CONSTRUCTION, 1986 including updates 1 through 6 (REFERRED TO HEREAFTER AS THE STANDARD SPECIFICATIONS), THE LATEST VERSION OF THE BERNALILLO COUNTY PUBLIC WORKS STANDARDS, OR AS MODIFIED BY THE PROJECT SPECIFICATIONS, WHICHEVER IS MORE STRINGENT.
- TWO (2) WORKING DAYS PRIOR TO ANY EXCAVATION, CONTRACTOR MUST CONTACT N.M. ONE-CALL SYSTEM, 260-1990, FOR LOCATION OF EXISTING UTILITIES.
- THE CONTRACTOR SHALL EXERCISE CARE TO AVOID DISTURBING EXISTING UNDERGROUND UTILITIES. IT SHALL BE HIS RESPONSIBILITY TO COORDINATE WITH THE UTILITY COMPANIES IN ORDER TO PREVENT ANY SERVICE DISRUPTION.
- PRIOR TO CONSTRUCTION, THE CONTRACTOR SHALL EXCAVATE AND VERIFY THE HORIZONTAL AND VERTICAL LOCATIONS OF ALL OBSTRUCTIONS. SHOULD A CONFLICT EXIST, THE CONTRACTOR SHALL NOTIFY THE CITY/COUNTY ENGINEER SO THAT THE CONFLICT CAN BE RESOLVED WITH MINIMUM AMOUNT OF DELAY.
- RELOCATION OF EXISTING UTILITIES AND THE INSTALLATION OF NEW UTILITY LINES WILL BE COMPLETED IN ADVANCE OF STARTING THE PAVEMENT WORK. TEMPORARY PAVEMENT WILL BE PLACED IN ALL TRENCHES REQUIRED FOR THE UTILITY REPLACEMENTS IN THOSE AREAS THAT MUST MAINTAIN TRAFFIC UNTIL THE PAVEMENT WORK STARTS IN EACH AREA. PAVEMENT REPLACEMENT MUST BEGIN WITHIN SEVEN (7) DAYS OF TRENCH CLOSURE. TEMPORARY STRIPING SHALL BE THE CONTRACTOR'S RESPONSIBILITY.
- ALL EXCAVATED MATERIAL THAT IS NOT REQUIRED TO BE REUSED MUST BE REMOVED FROM THE PROJECT AREA WITHIN FOUR DAYS OF EXCAVATION. SPOIL PILES WILL BE ALLOWED ONLY AS APPROVED BY THE CITY/COUNTY ENGINEER.
- THE CONTRACTOR SHALL COORDINATE HIS CONSTRUCTION ACTIVITIES WITH ALL OTHER CONTRACTORS AND UTILITY COMPANIES WORKING IN THE SAME AREA. THE CONTRACTOR MAY BE REQUIRED TO RESCHEDULE THEIR ACTIVITIES TO ALLOW UTILITY CREWS TO PERFORM THEIR REQUIRED WORK. NO ADDITIONAL COMPENSATION WILL BE ALLOWED FOR DELAYS OR INCONVENIENCE CAUSED BY UTILITY COMPANY WORK CREWS.
- WHEN ABUTTING NEW PAVEMENT TO EXISTING, CONTRACTOR SHALL SAW (MILL) CUT EXISTING PAVEMENT TO A NEAT, STRAIGHT LINE, AS REQUIRED, TO REMOVE ANY BROKEN OR CRACKED PAVEMENT AND MATCH NEW TO EXISTING.
- CONTRACTOR IS RESPONSIBLE FOR REMOVAL AND DISPOSAL OF ALL DEMOLITION DEBRIS. SALVAGE OF ANY MATERIAL SHALL BE IDENTIFIED BY THE CITY/COUNTY ENGINEER. WORK MATERIALS SHALL BE DISPOSED OF IN CITY APPROVED WASTE AREAS SECURED BY AND AT THE EXPENSE OF THE CONTRACTOR.
- ALL UTILITY LINES WHICH ARE NOT SPECIFICALLY DESIGNATED TO BE REMOVED AND REPLACED ON THE PLANS SHALL BE MAINTAINED IN SERVICE. SHORING, SHEETING, AND OTHER MEANS OF SUPPORT SHALL BE EMPLOYED BY THE CONTRACTOR TO PREVENT DAMAGE OR LOSS OF THESE EXISTING UTILITIES. BEAM AND CABLE OR OTHER ADEQUATE SUPPORTS SHALL BE USED FOR TEMPORARY SUPPORT OF ALL UTILITY LINES WHICH CROSS THE TRENCH. ANY DAMAGE TO EXISTING UTILITIES SHALL PROMPTLY BE REPAIRED AT THE CONTRACTOR'S EXPENSE. THE ENGINEER WILL BE IMMEDIATELY NOTIFIED OF ANY SIGNIFICANT DEVIATION OF EXPOSED UTILITIES FROM THE LOCATIONS SHOWN ON THE PLANS SO THAT CONFLICTS CAN BE RESOLVED IN A TIMELY MANNER.

SCANNED BY
MESA REPRO

*PAVING CHART

STREET	WIDTH
Jennie Road	24'
Kirsten Road	24'

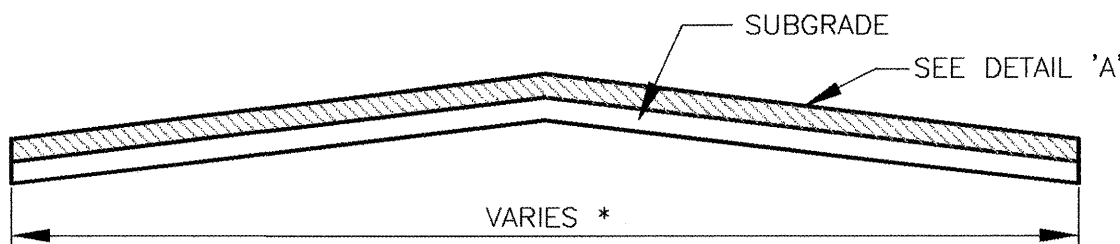


SECTION 'A'

* WILL VARY ACCORDING TO PAVING CHART.

TRAFFIC CONTROL GENERAL NOTES:

- SUBJECT TO THE APPROVED TRAFFIC CONTROL PLAN, AT LEAST ONE LANE SHALL BE OPEN TO TRAFFIC AT ALL TIMES. CONTRACTOR SHALL PROVIDE PROPER SIGNAGE AND FLAGMEN AND SHALL MAINTAIN THE TRAFFIC LANES IN SUCH A MANNER AS TO ASSURE PROPER SAFETY TO THE TRAVELLING PUBLIC ON ALL AFFECTED ROADS. THE CONTRACTOR SHALL PROVIDE ACCESS TO ALL PRIVATE AND PUBLIC PROPERTY AT ALL TIMES, EXCEPT WHEN GRADING, PAVING, EXCAVATION AND BACKFILL OPERATIONS ARE BEING CONDUCTED IMMEDIATELY IN FRONT OF THE PROPERTY, IN WHICH CASE ACCESS WILL NOT BE DENIED FOR MORE THAN 4 HOURS WITHOUT APPROVAL BY THE COUNTY.
- TRAFFIC LANES PROVIDED DURING CONSTRUCTION SHALL BE MAINTAINED, IN SUCH A CONDITION UNDER ALL WEATHER CONDITIONS, SO AS TO PERMIT THE REASONABLE PASSAGE OF PASSENGER VEHICLES, AND SHALL BE KEPT GRADED AND SMOOTH, AND WATERED SEVERAL TIMES DAILY TO CONTROL DUST.
- A DAILY TRAFFIC CONTROL LOG SHALL BE MAINTAINED BY THE CONTRACTOR REFLECTING THE TYPES AND LOCATIONS OF ALL TRAFFIC CONTROL DEVICES, SIGNS, BARRICADES, ETC. BEING USED ON THE PROJECT IN COMPLIANCE WITH THE APPROVED TRAFFIC CONTROL PLAN. THIS LOG SHALL BE SUBMITTED TO THE BERNALILLO COUNTY TRAFFIC CONTROL MANAGER UPON COMPLETION OF THE PROJECT CONSTRUCTION OR WHEN SO REQUESTED BY THE PROJECT OR THE BERNALILLO COUNTY TRAFFIC CONTROL MANAGER.
- ALL NEW STREET PAVING ABUTTING EXISTING AREAS SHALL MATCH THE ELEVATIONS OF THOSE AREAS.
- CONTRACTOR SHALL PROVIDE A WEEKLY CONSTRUCTION ACTIVITY SCHEDULE TO BERNALILLO COUNTY PUBLIC WORKS DEPARTMENT, ATTN: HOSS FOSTER.
- PROJECT IS SUBJECT TO THE REQUIREMENTS OF COUNTY ORDINANCE NO. 95-12 AND ORDINANCE NO. 96-3. THE CONTRACTOR IS RESPONSIBLE FOR ACQUIRING ALL PERMITS NECESSARY. CONTRACTOR SHALL CALL 848-1500 FOR MORE INFORMATION.
- PRIOR TO CONSTRUCTION, THE CONTRACTOR SHALL CONTACT THE MIDDLE RIO GRANDE CONSERVANCY DISTRICT (MRGCD) AT 247-0234 TO PROVIDE NOTICE OF THE SCHEDULE FOR CONSTRUCTION AT THE MRGCD FACILITIES. ALL WORK TO BE PERFORMED IN THE MRGCD RIGHT-OF-WAY SHALL BE CLOSELY COORDINATED WITH MRGCD.
- THE CONTRACTOR SHALL SUBMIT A TRAFFIC CONTROL PLAN TO THE COUNTY TRAFFIC CONTROL MANAGER AND TO THE NEW MEXICO STATE HIGHWAY AND TRANSPORTATION DEPARTMENT AT LEAST 48 HOURS PRIOR TO COMMENCEMENT OF WORK. TRAFFIC CONTROL PLANS SHALL BE PREPARED IN ACCORDANCE WITH MUTCD REQUIREMENTS AND BY CERTIFIED PERSONNEL AND MUST BE APPROVED PRIOR TO COMMENCEMENT OF WORK ON THE PROJECT. CALL 848-1504 FOR FURTHER INFORMATION.
- THE CONTRACTOR SHALL PROVIDE A BARRICADING BOND TO COUNTY.

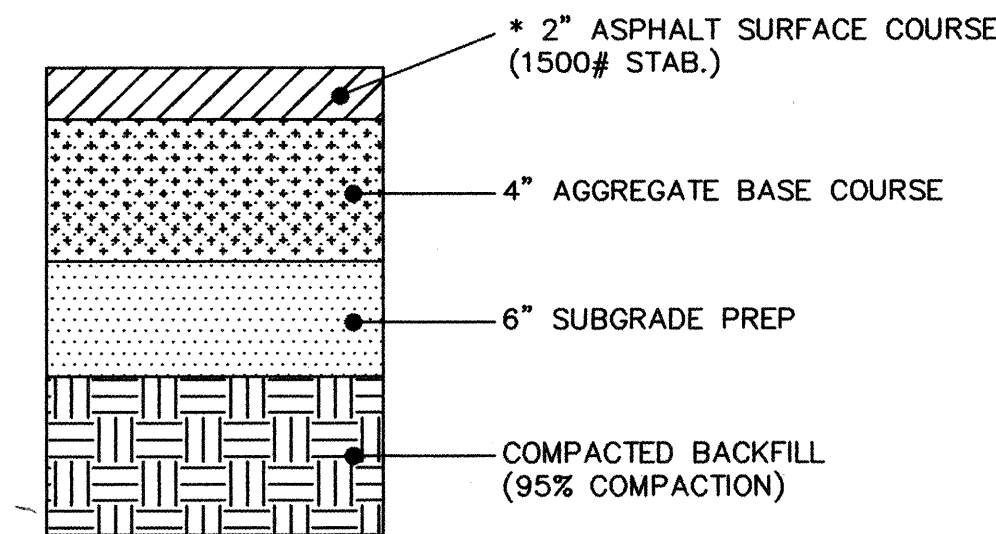

PAVEMENT DETAIL "A"

R-VALUE IS 35
N.T.S.

AS BUILT INFORMATION		CONTRACTOR		CONTRACT NO.		DATE		1998	
BENCH MARKS		7-101, City of Albuquerque bench mark, the station is a standard 45 3 1/4\"/>		7-101,1988		DATE		1998	
SURVEY INFORMATION		FIELD NOTES		DATE		BY		DATE	
ENGINEER'S SEAL		NO.		DATE		BY		DATE	
REMARKS		REVISIONS		DESIGN		DATE		2/1998	
DRAWN BY		GRH		DATE		2/1998		CHECKED BY	
JL		DATE		2/1998		DESIGNED BY		BZ	
NO.		DATE		2/1998		RECORDED BY		DATE	
MICRO-FILM INFORMATION		CORRECTED BY		HDR		DATE		1998	
RECORDED BY		DATE		2/1998		NO.		DATE	

"AS RECORDED"

From information
provided by the
contractors

By *JS* Date *12/1/98*

HDR



HDR Engineering, Inc.

BERNALILLO COUNTY
PUBLIC WORKS DEPARTMENT

TITLE: COORS PARK AND DESERT PALMS SEWER PROJECT
GEN. NOTES/MISC. DETAILS

Design Review Committee	City Engineer Approval	Mr. Ray/ty	Mr. Ray/ty

PROJECT NO.	5737.90	FILE NAME	GEN_BC	SHEET	2	OF	16
-------------	---------	-----------	--------	-------	---	----	----

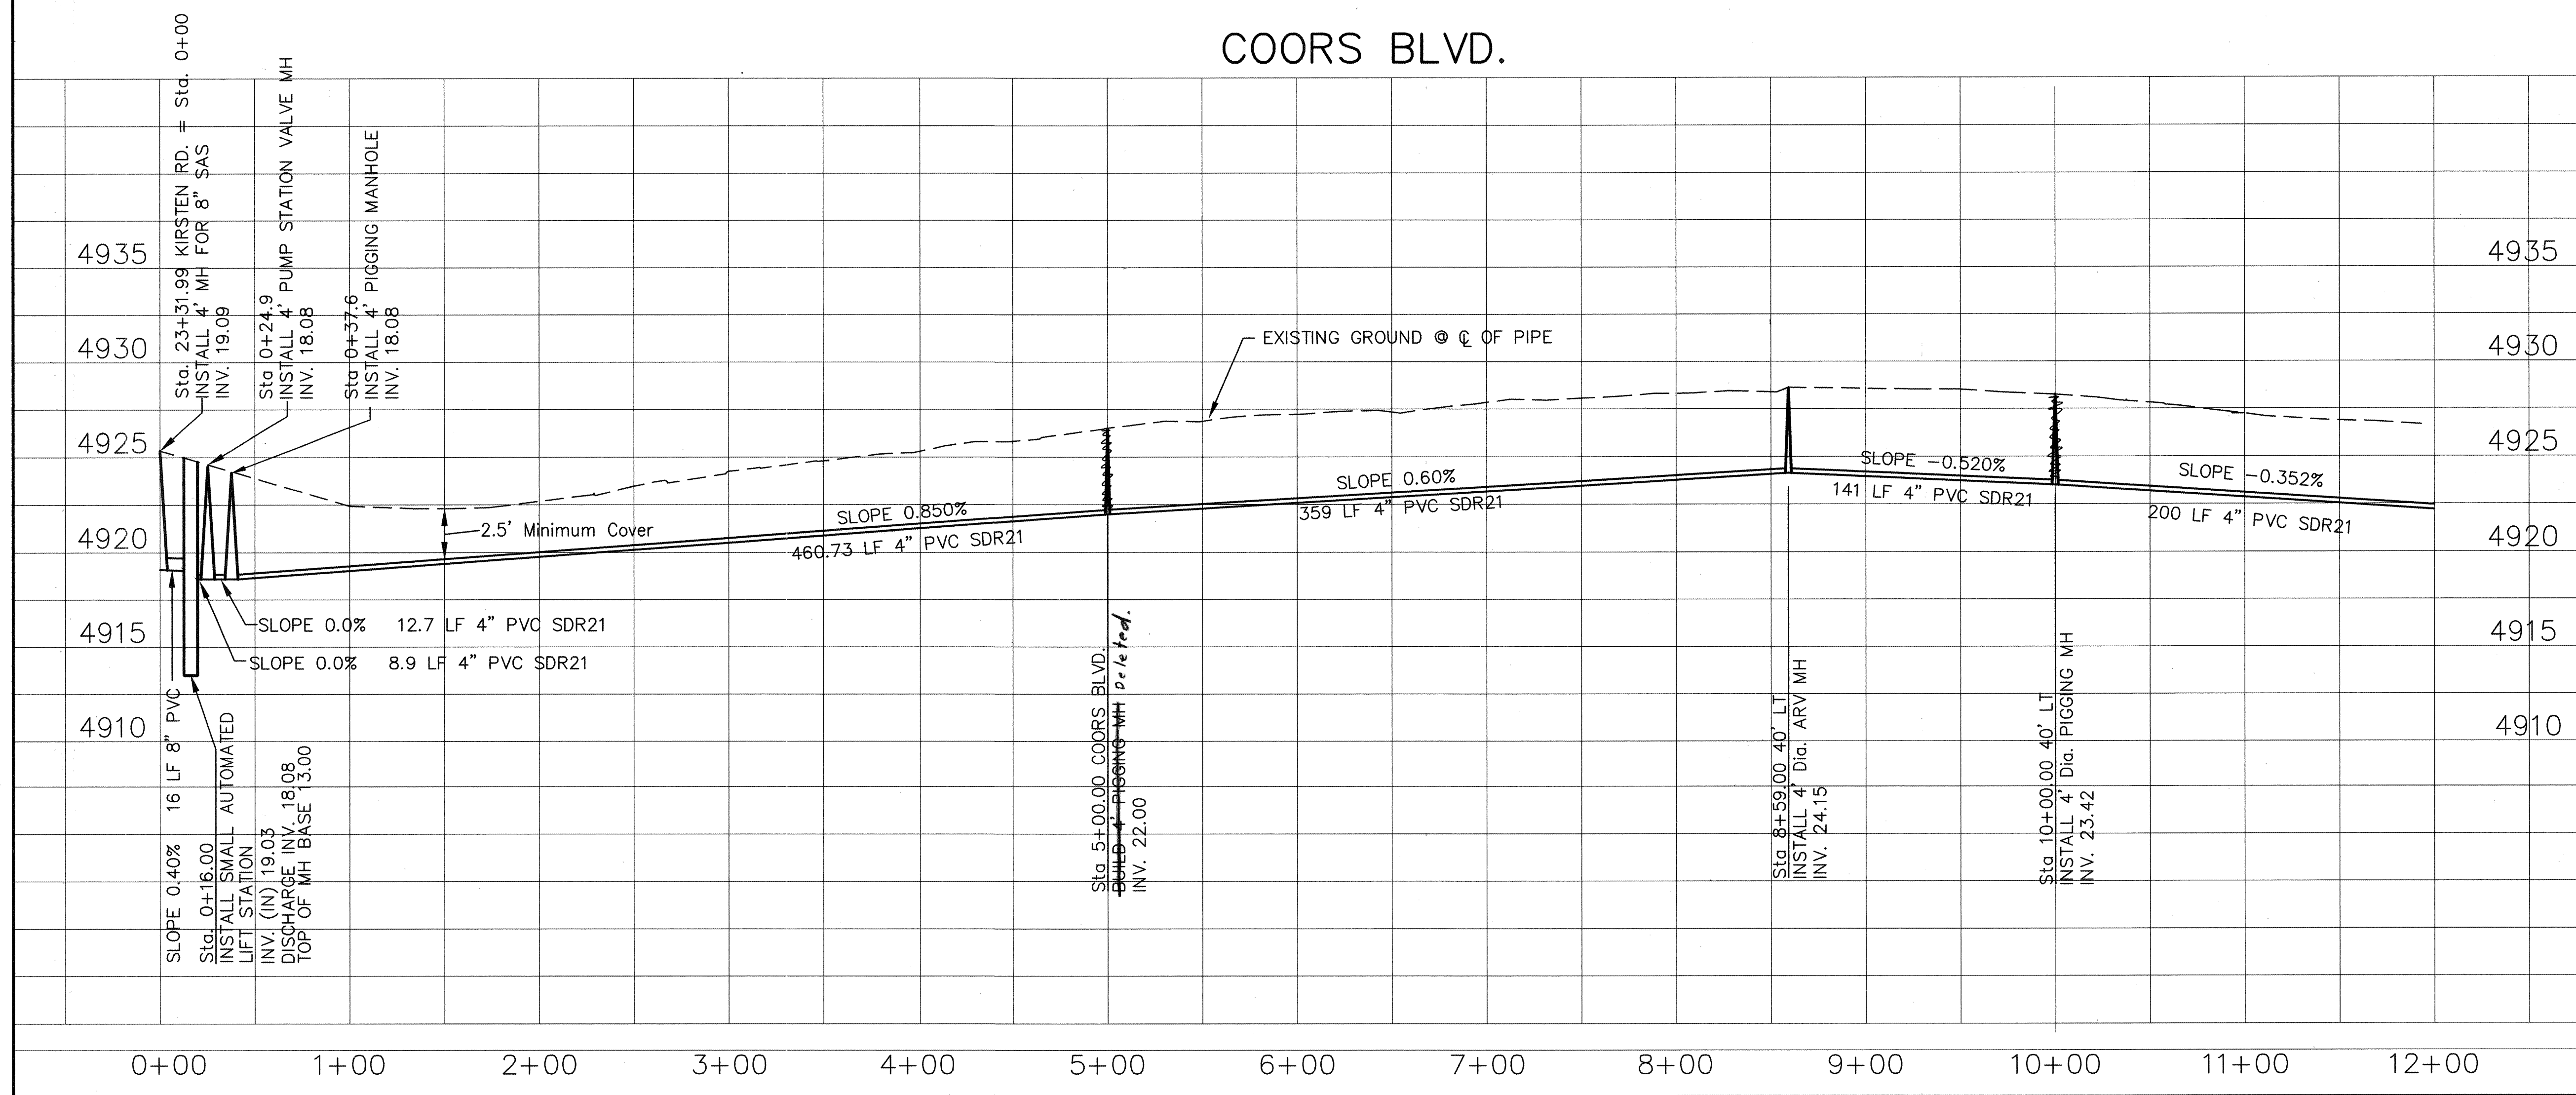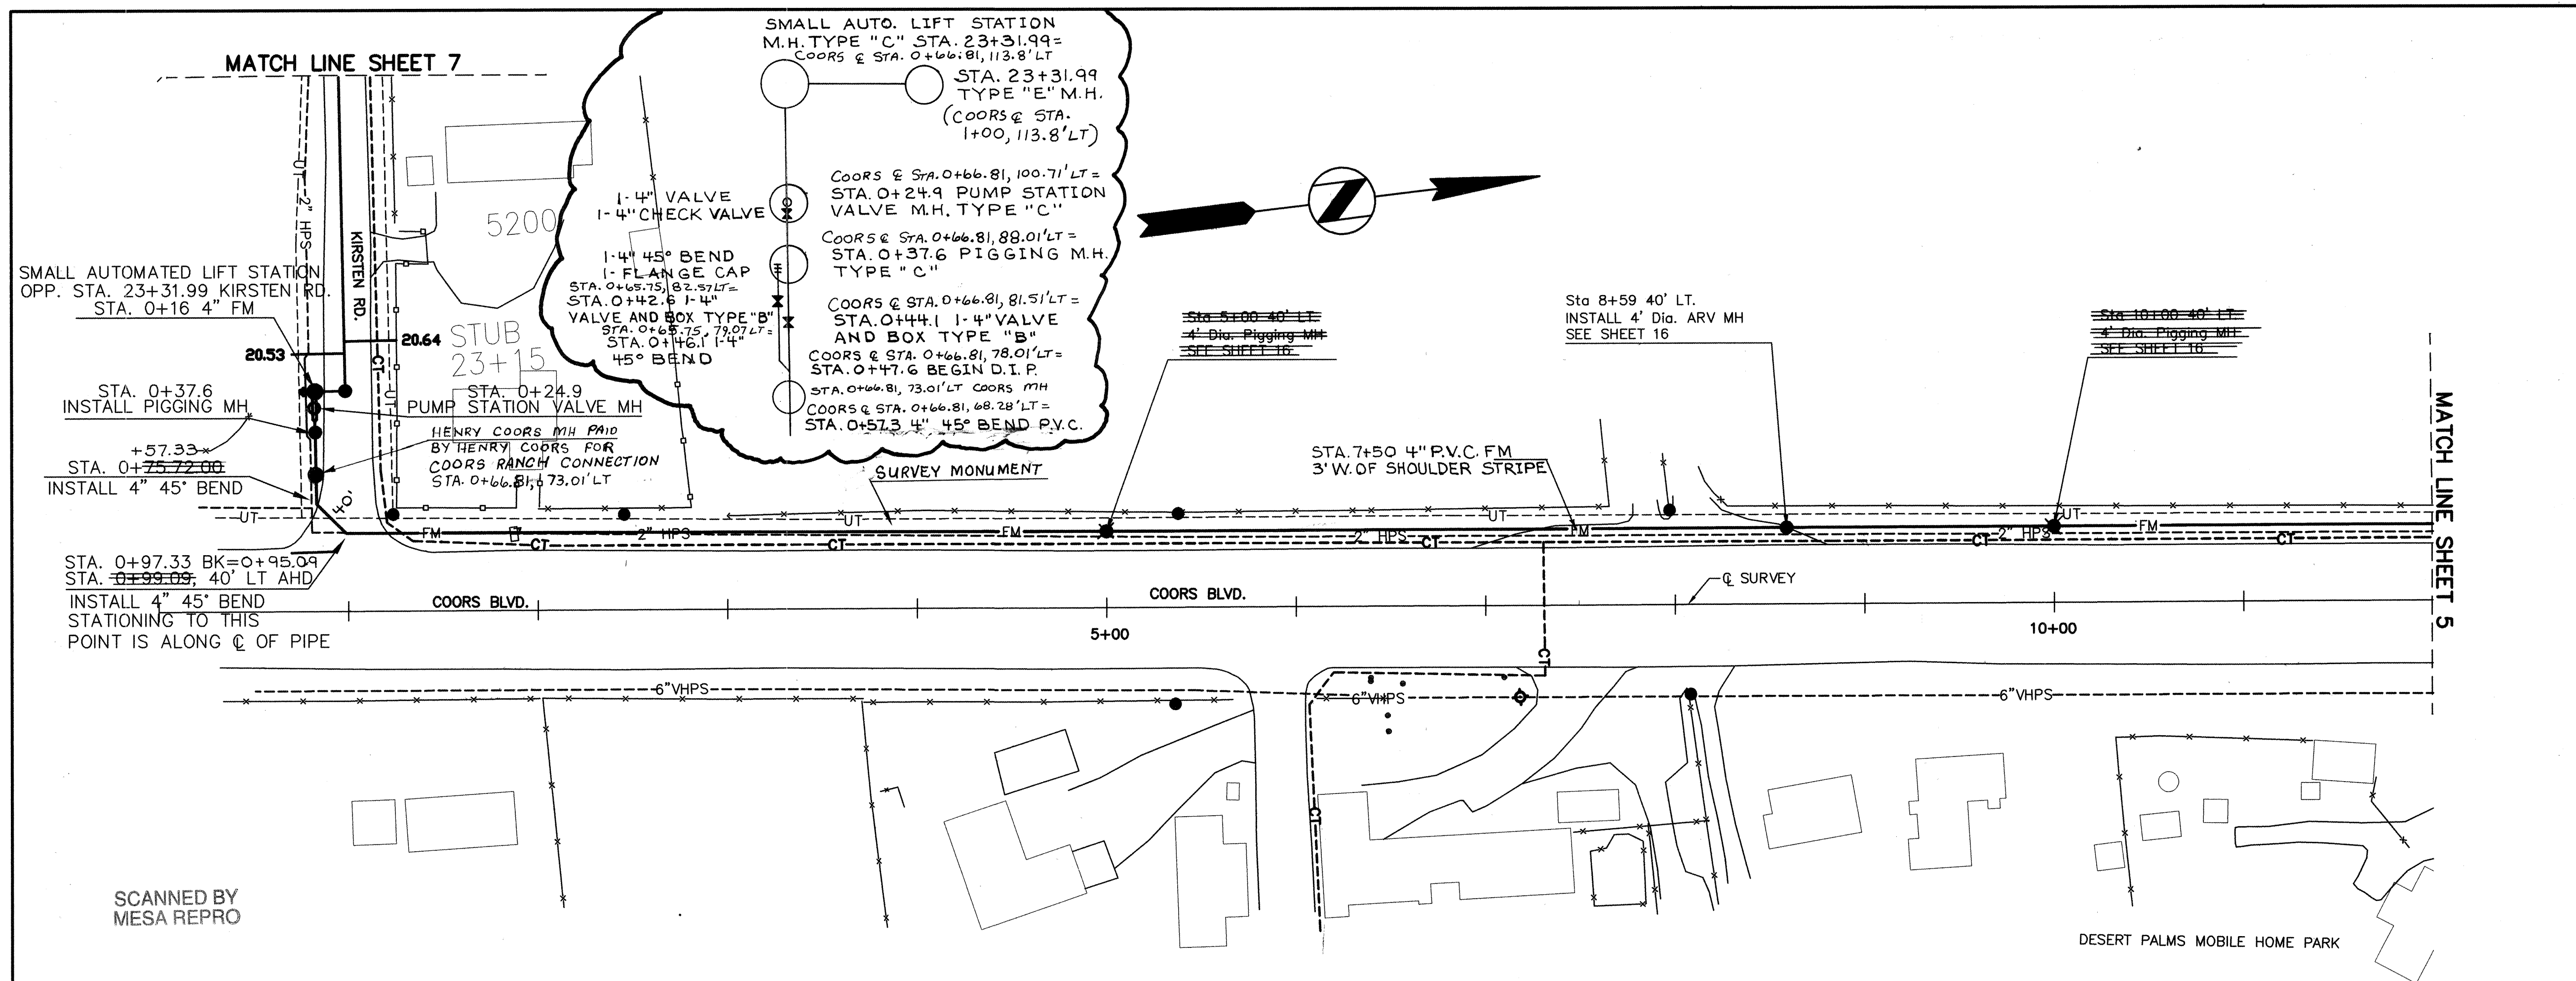

PLAN
SCALE: 1"=50'

PROFILE
SCALE: 1"=50' HOR
1"=5' VERT

LEGEND

NEW

EXIST.

FM

GAS

HS

CT

2" HPS

6" VHS

UT

UE

W

FORCE MAIN

SANITARY SEWER LINE

SAS HOUSE SERVICE

MANHOLE

CATV

2" GAS LINE

6" GAS LINE

UNDERGROUND TELEPHONE LINE

SEPTIC TANK

UNDERGROUND ELECTRICAL LINE

OVERHEAD POWER POLE W/ GUY WIRE

WELL

AS BUILT INFORMATION

CONTRACTOR: *Concor Const* DATE: 1998

STAMPED BY: *BZ* DATE: 1998

FIELD NOTES: *HDR* DATE: 1998

REVISIONS: *HDR* DATE: 1998

CHECKED BY: *HDR* DATE: 1998

RECORDED BY: *HDR* DATE: 1998

SURVEY INFORMATION

FIELD NOTES

NO.

BY

DATE

ENGINEER'S SEAL

7. JIMENEZ
12/16/98

"AS RECORDED"

From information provided by the contractors

By *JS* Date *12/16/98*

HDR

HDR Engineering, Inc.

BERNALILLO COUNTY
PUBLIC WORKS DEPARTMENT

TITLE: COORS PARK AND DESERT PALMS SEWER PROJECT
FORCEMAIN

Design Review Committee



City Engineer Approval

Last Design Update

PROJECT NO. 5737.90

FILE NAME BC_04

SHEET 4 OF 16

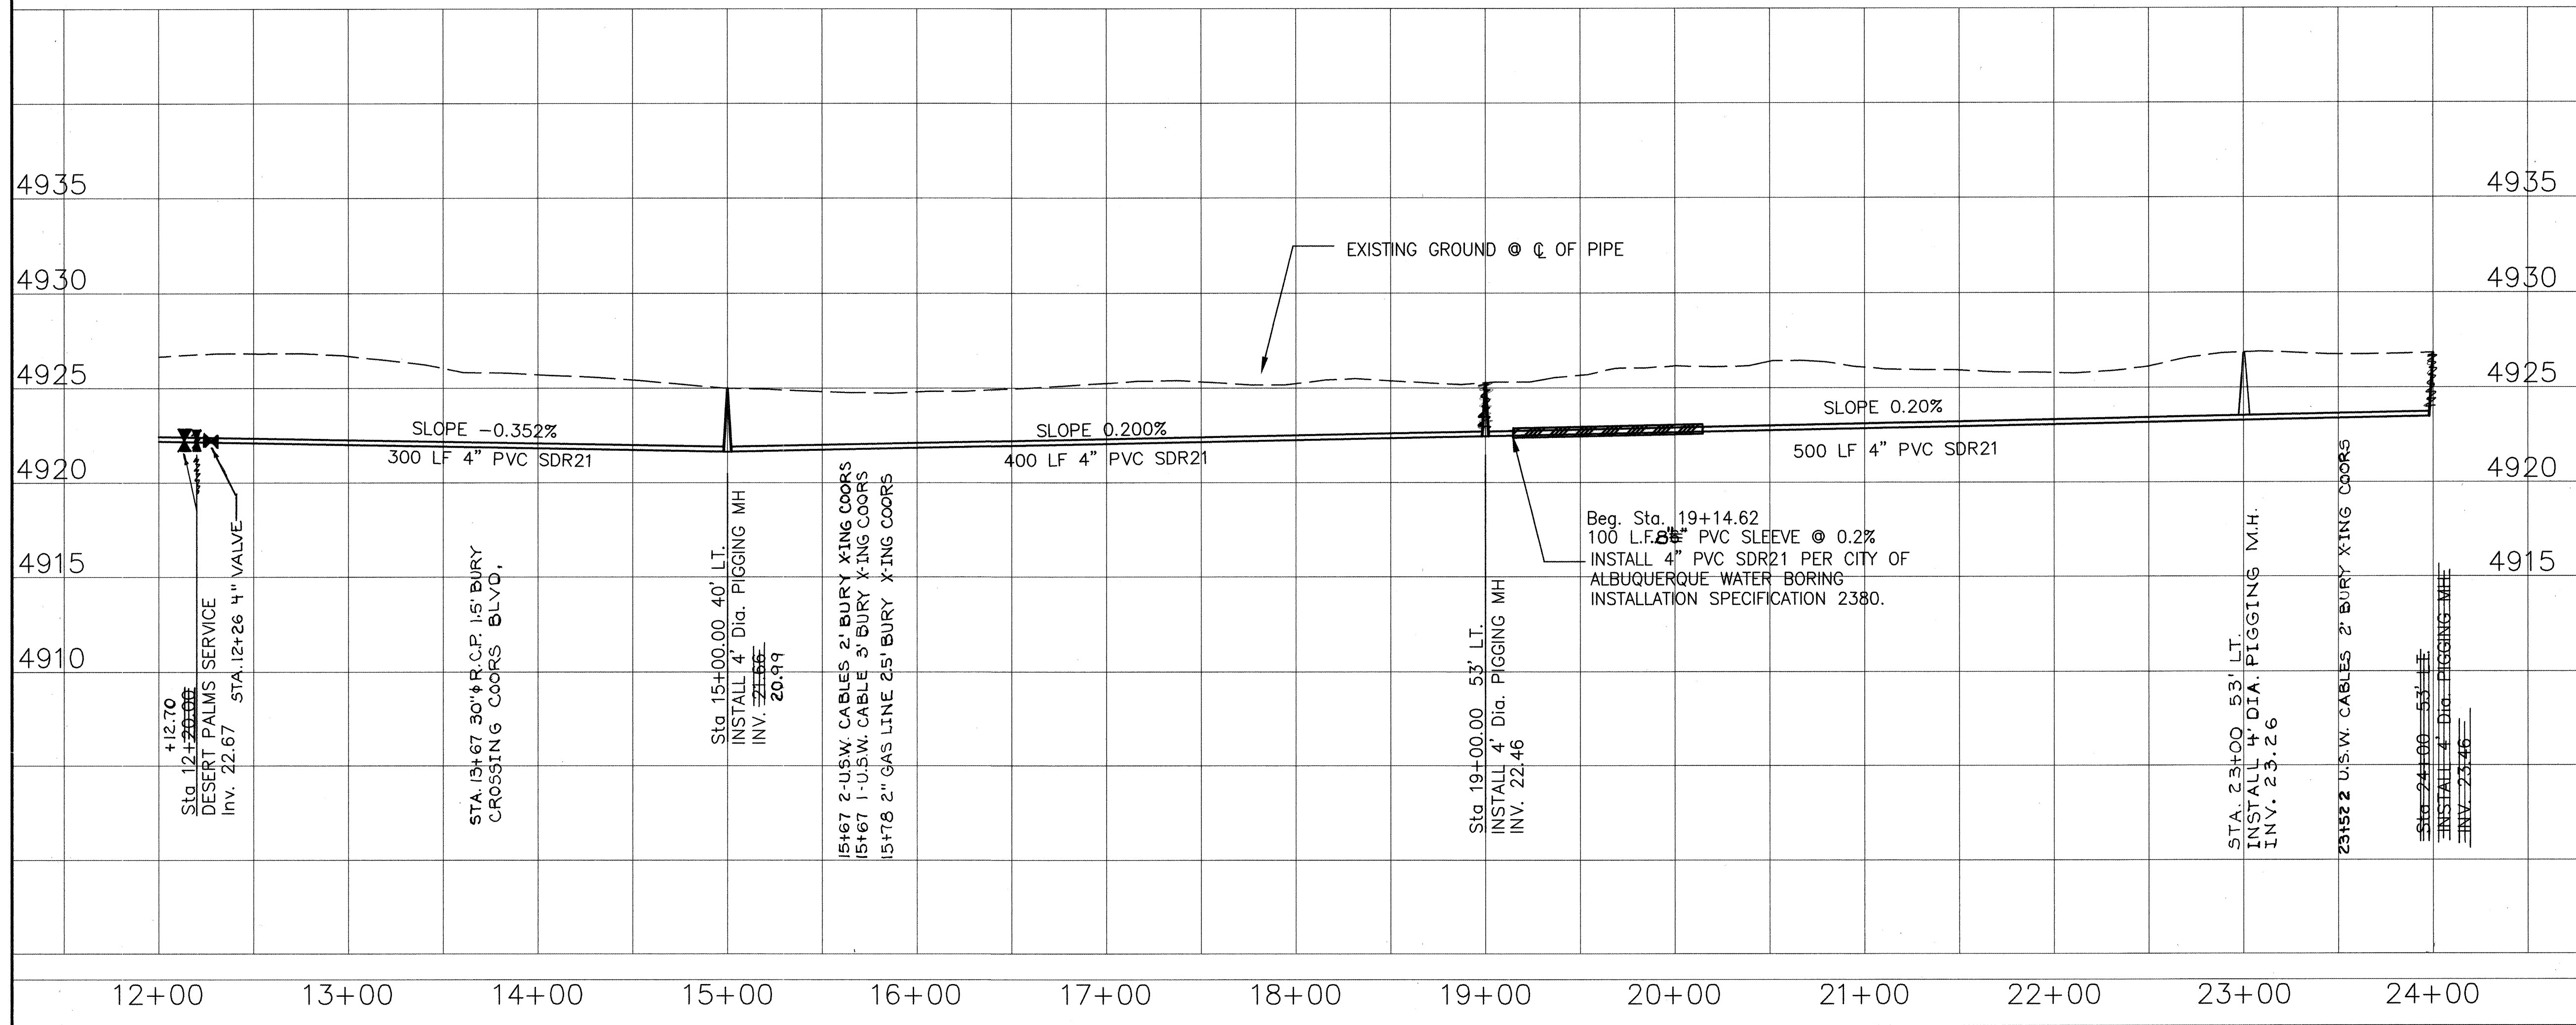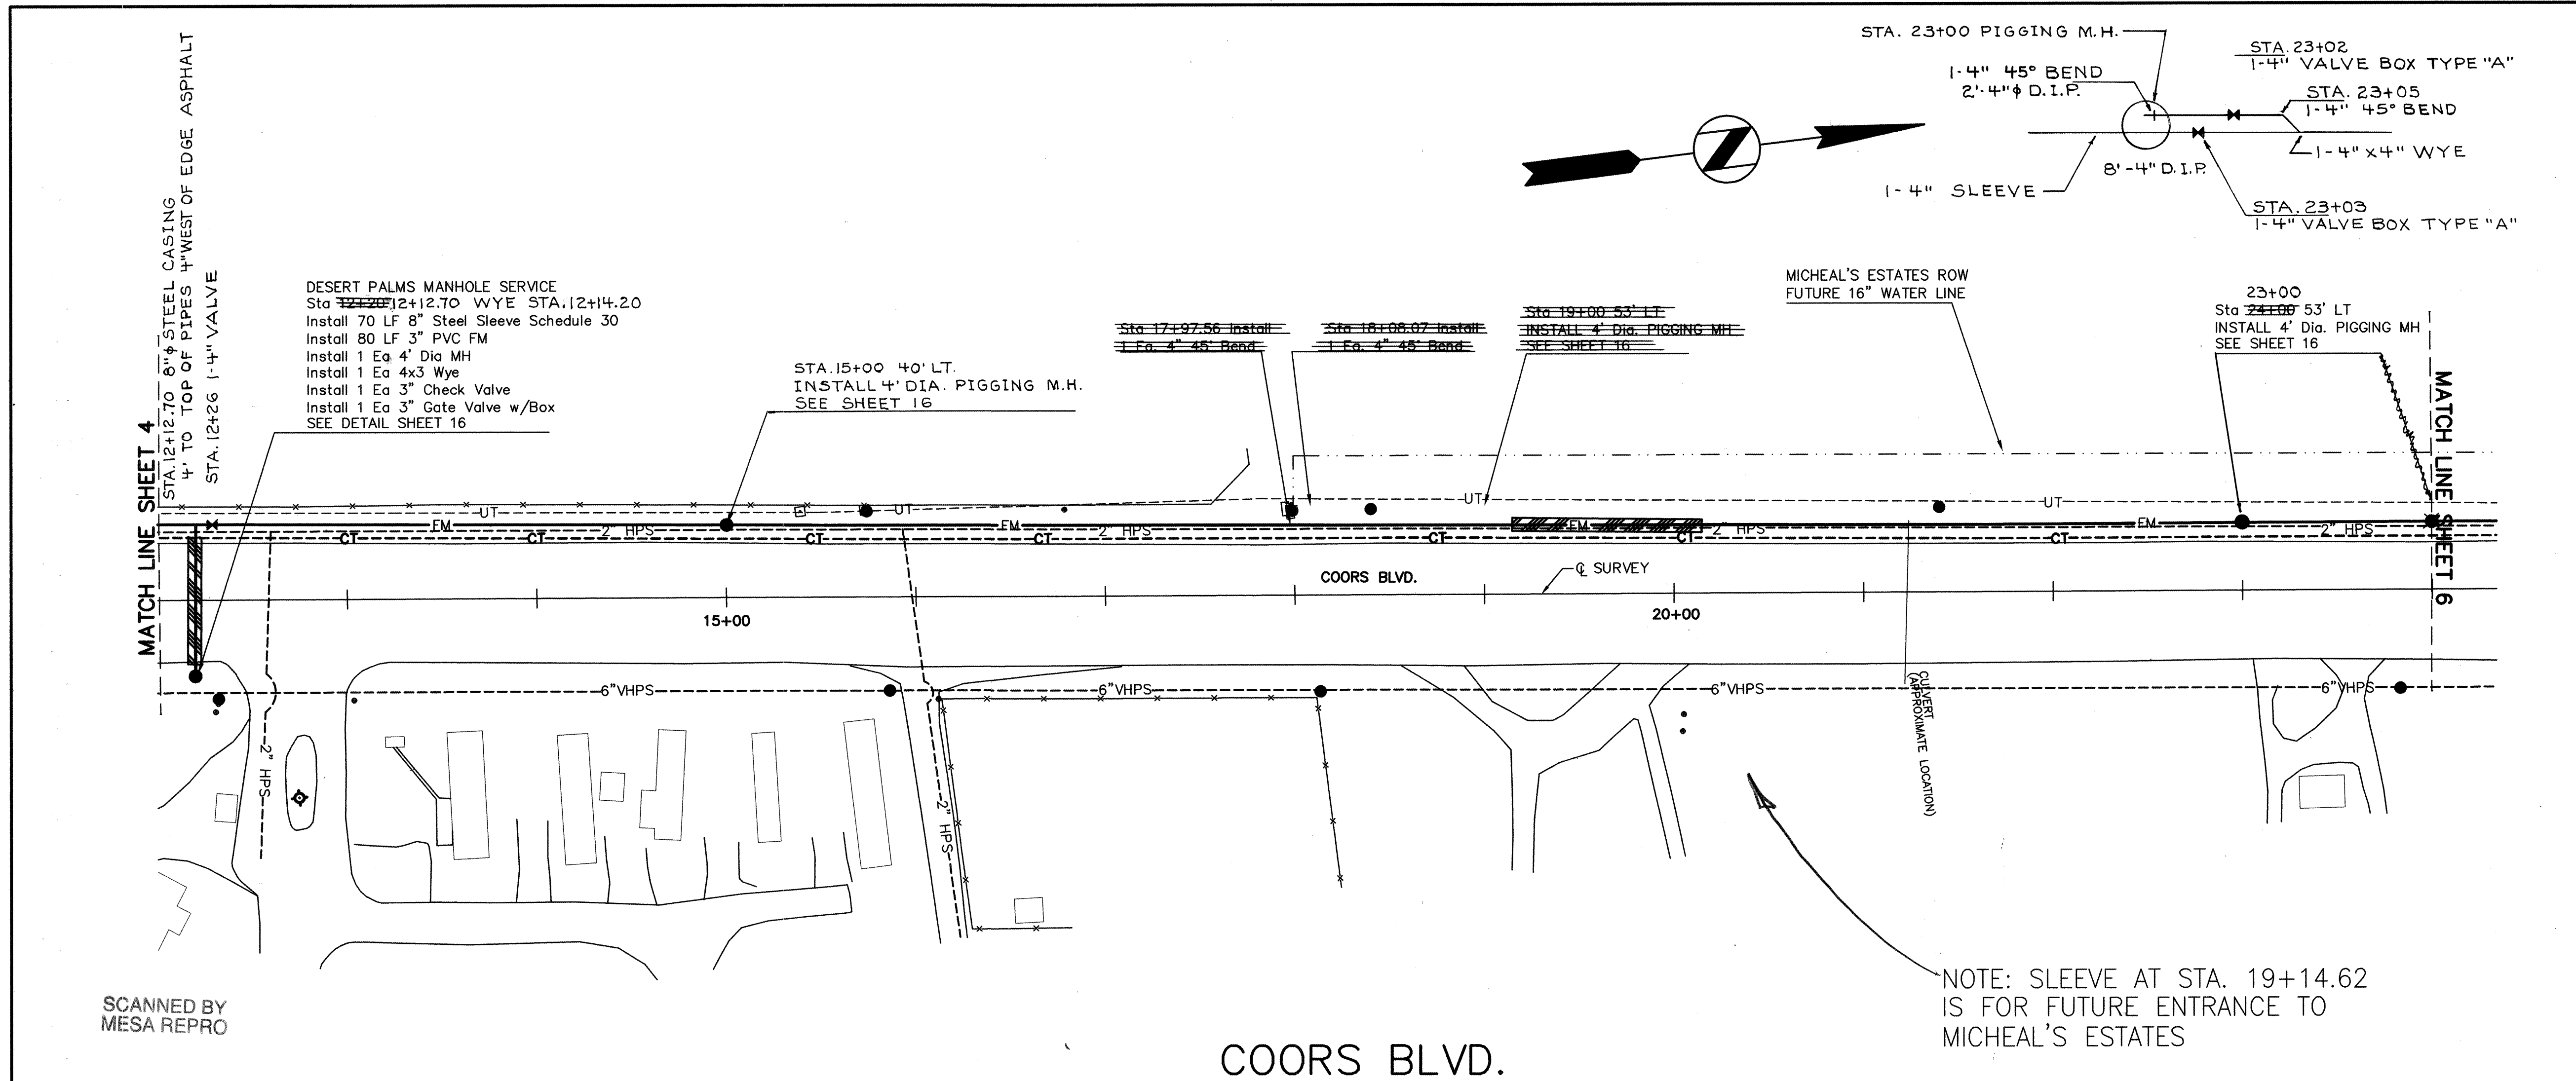

PLAN
SCALE: 1"=50'

PROFILE
SCALE: 1"=50' HOR
1"=5' VERT

LEGEND

NEW	EXIST.	
FM	FM	FORCE MAIN
SAS	SAS	SANITARY SEWER LINE
HS	HS	SAS HOUSE SERVICE
CT	CT	MANHOLE
CT	CT	CATV
2" HPS	2" HPS	2" GAS LINE
6" VHP	6" VHP	6" GAS LINE
UT	UT	UNDERGROUND TELEPHONE LINE
SEPTIC TANK	SEPTIC TANK	SEPTIC TANK
UE	UE	UNDERGROUND ELECTRICAL LINE
POLE W/ GUY WIRE	POLE W/ GUY WIRE	OVERHEAD POWER POLE W/ GUY WIRE
WELL	WELL	WELL

AS BUILT INFORMATION

CONTRACTOR: *Condor Construction*

DATE: 1998

DATE: 1998

DATE: 1998

DATE: 1998

DATE: 1998

DATE: 1998

BENCH MARKS

7-010, City of Albuquerque bench mark, the station is a standard 3.1/4" aluminum cap fitted to a pipe 0.25' above ground and is stamped 7-010, 1988. Station is located at intersection of Sun Club and Kirk Line on the north side of intersection.

SURVEY INFORMATION

FIELD NOTES

NO. BY DATE

ENGINEER'S SEAL

10/10/98

10/10/98

10/10/98

10/10/98

10/10/98

10/10/98

"AS RECORDED"

From information provided by the contractors

By: *DS* Date: 12/9/99

HDR

HDR Engineering, Inc.

TITLE:

COORS PARK AND DESERT PALMS SEWER PROJECT

FORCEMAIN

DESIGN REVIEW COMMITTEE

City Engineer Approval

PROJECT NO.



5737.90

FILE NAME

BC_05

SHEET

5 OF 16

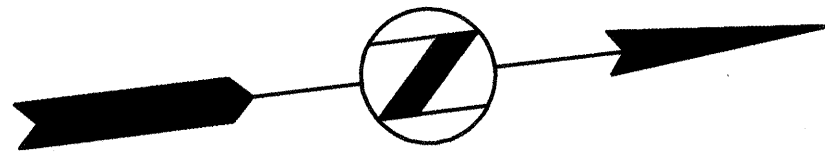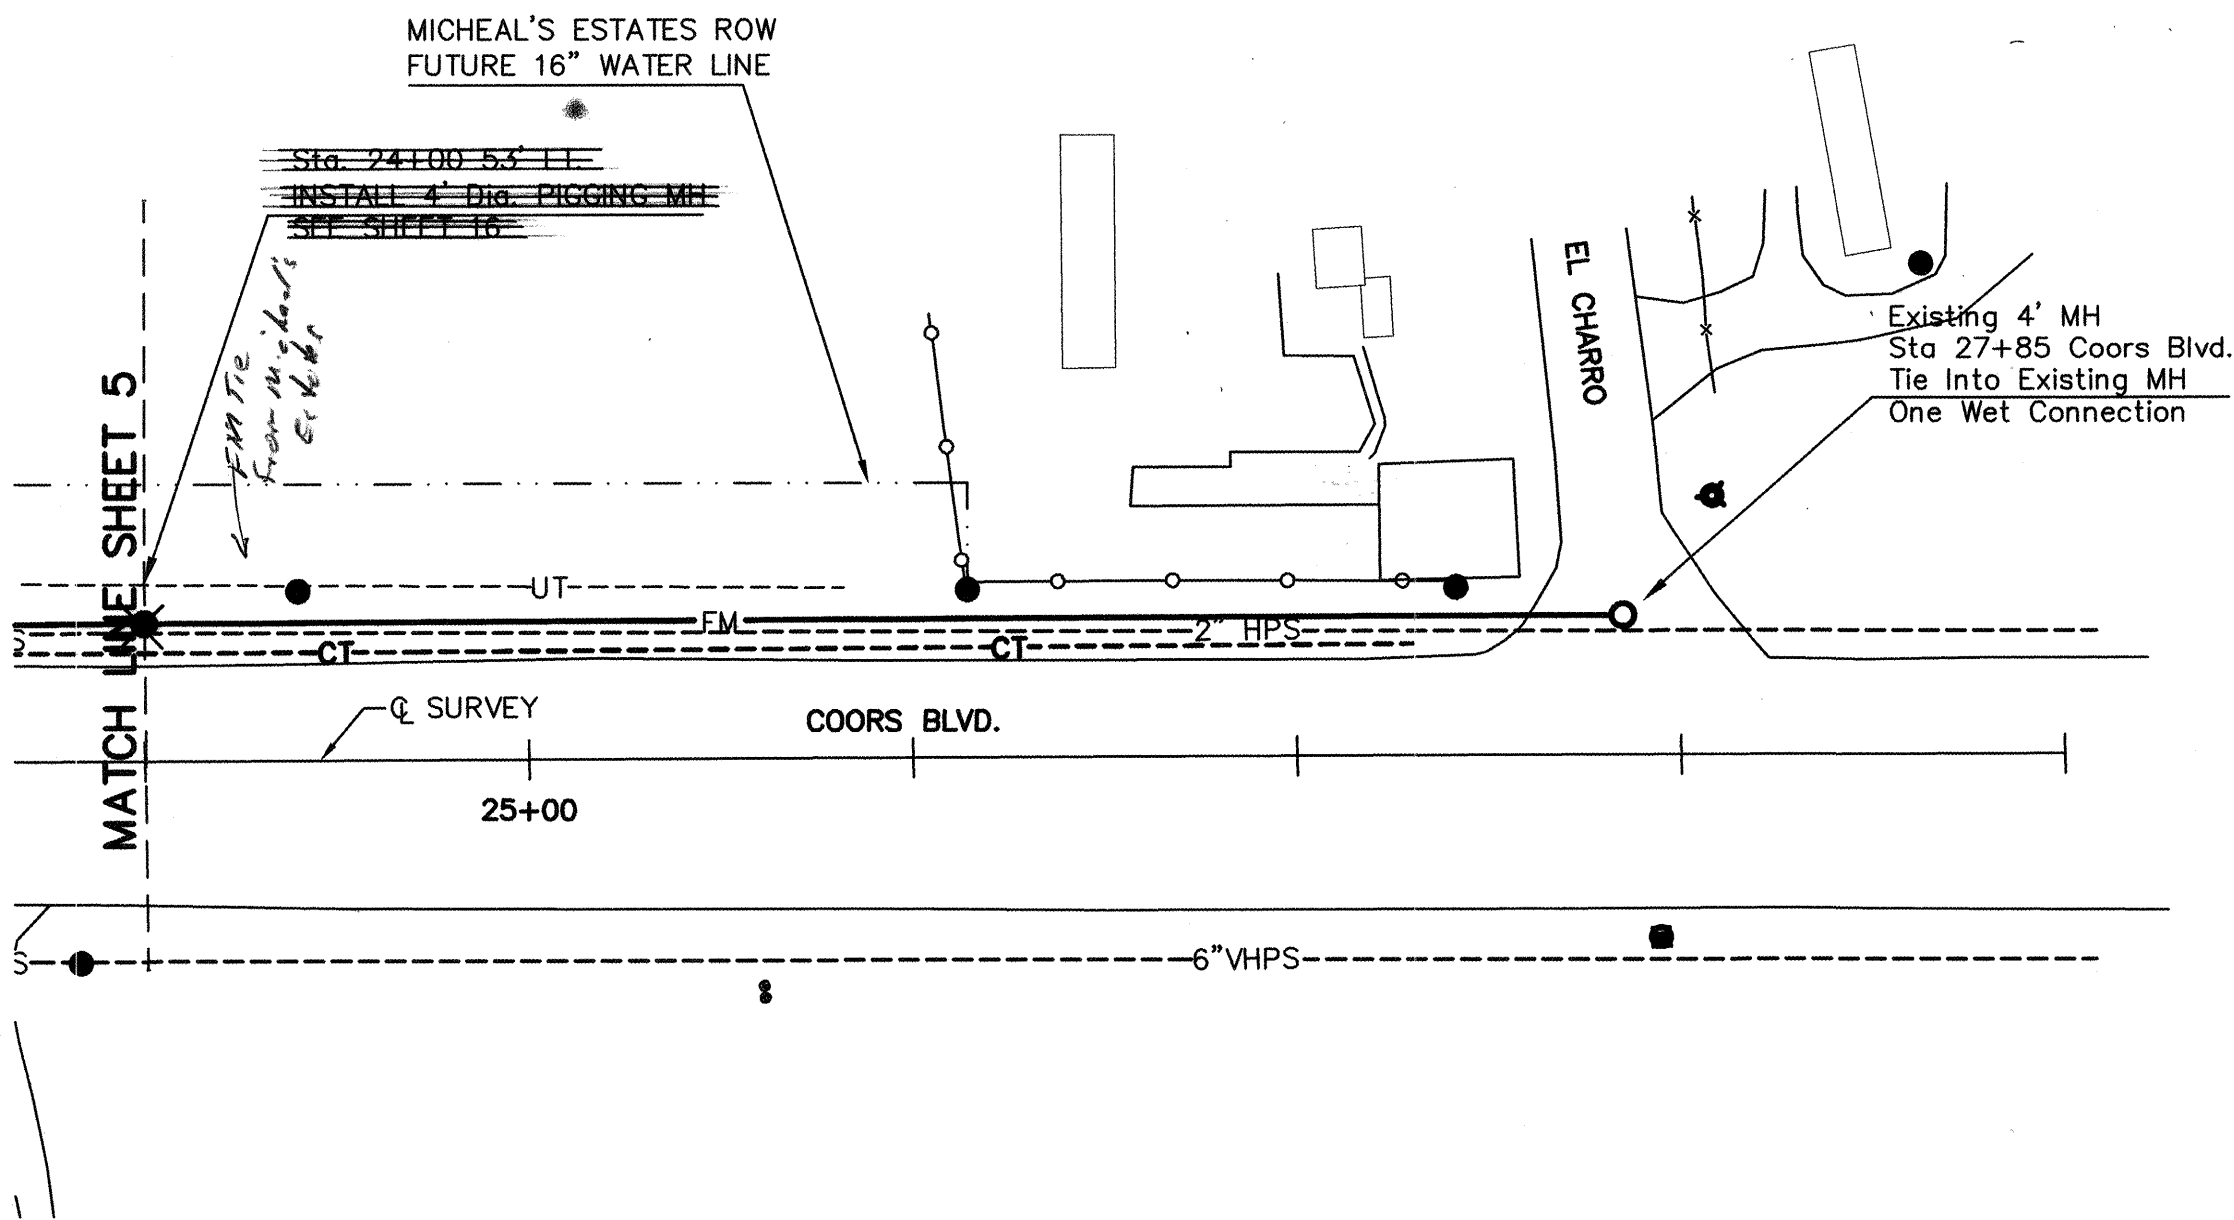

SCANNED BY
MESA REPRO

COORS BLVD.

4935

4935

4930

4930

4925

4925

4920

4920

4915

4915

4910

EXISTING GROUND @ Q OF PIPE


385 L.F. 4" FM
SLOPE 0.2%

Sta 27+85.00 COORS BLVD.
EXISTING 4" MH

24+00 25+00 26+00 27+00 28+00 29+00 30+00

PLAN
SCALE: 1"=50'

PROFILE
SCALE: 1"=50' HOR
1"=5' VERT

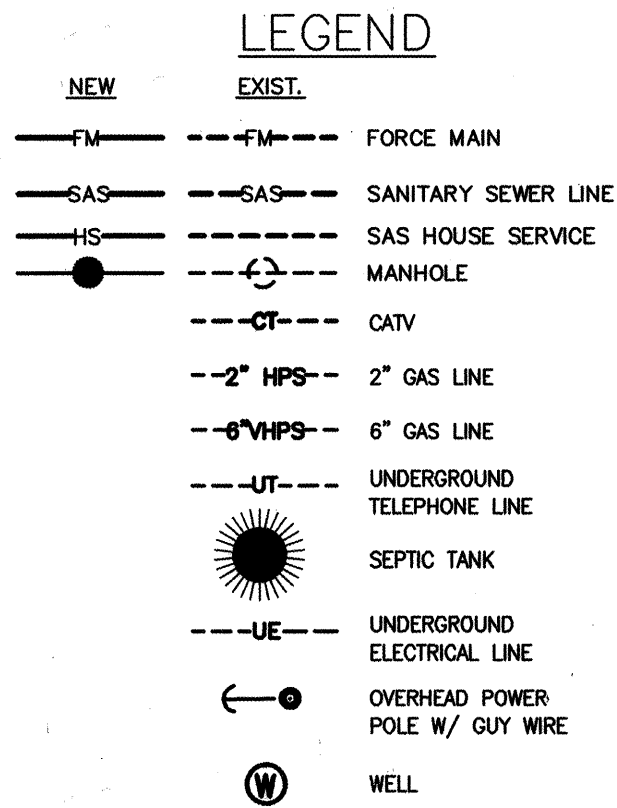

AS BUILT INFORMATION	
CONTRACTOR	CONCOR
DATE	1998
WORK STARTED BY	
ACCEPTANCE BY	HDR
DATE	1998
FIELD LOCATION BY	HDR
DATE	1998
DRAWINGS	
CORRECTED BY	HDR
DATE	1998
MICRO-FILM INFORMATION	
RECORDED BY	
DATE	
NO.	

BENCH MARKS	
7-010, City of Albuquerque bench mark, the station is a standard ACS 3 1/4" aluminum cap riveted to a pipe 0.25' above ground and is stamped 7-010, 1988.	
Station is located at intersection of Sun Club and Kirk Lane on the north side of intersection.	

SURVEY INFORMATION	
FIELD NOTES	DATE
BY	
NO.	

ENGINEER'S SEAL	
WILLIAM S. ZIMMERMAN REGISTERED PROFESSIONAL ENGINEER No. 12345 State of New Mexico	07/16/98

"AS RECORDED"

From Information
provided by the
contractors

By *DS* Date *12/19/98*



HDR
HDR Engineering, Inc.

BERNALILLO COUNTY
PUBLIC WORKS DEPARTMENT

TITLE: COORS PARK AND DESERT PALMS SEWER PROJECT
FORCE MAIN

Design Review Committee	City Engineer Approval	No./Rev./%	No./Rev./%

PROJECT NO. 5737.90 FILE NAME BC_06 SHEET 6 OF 16

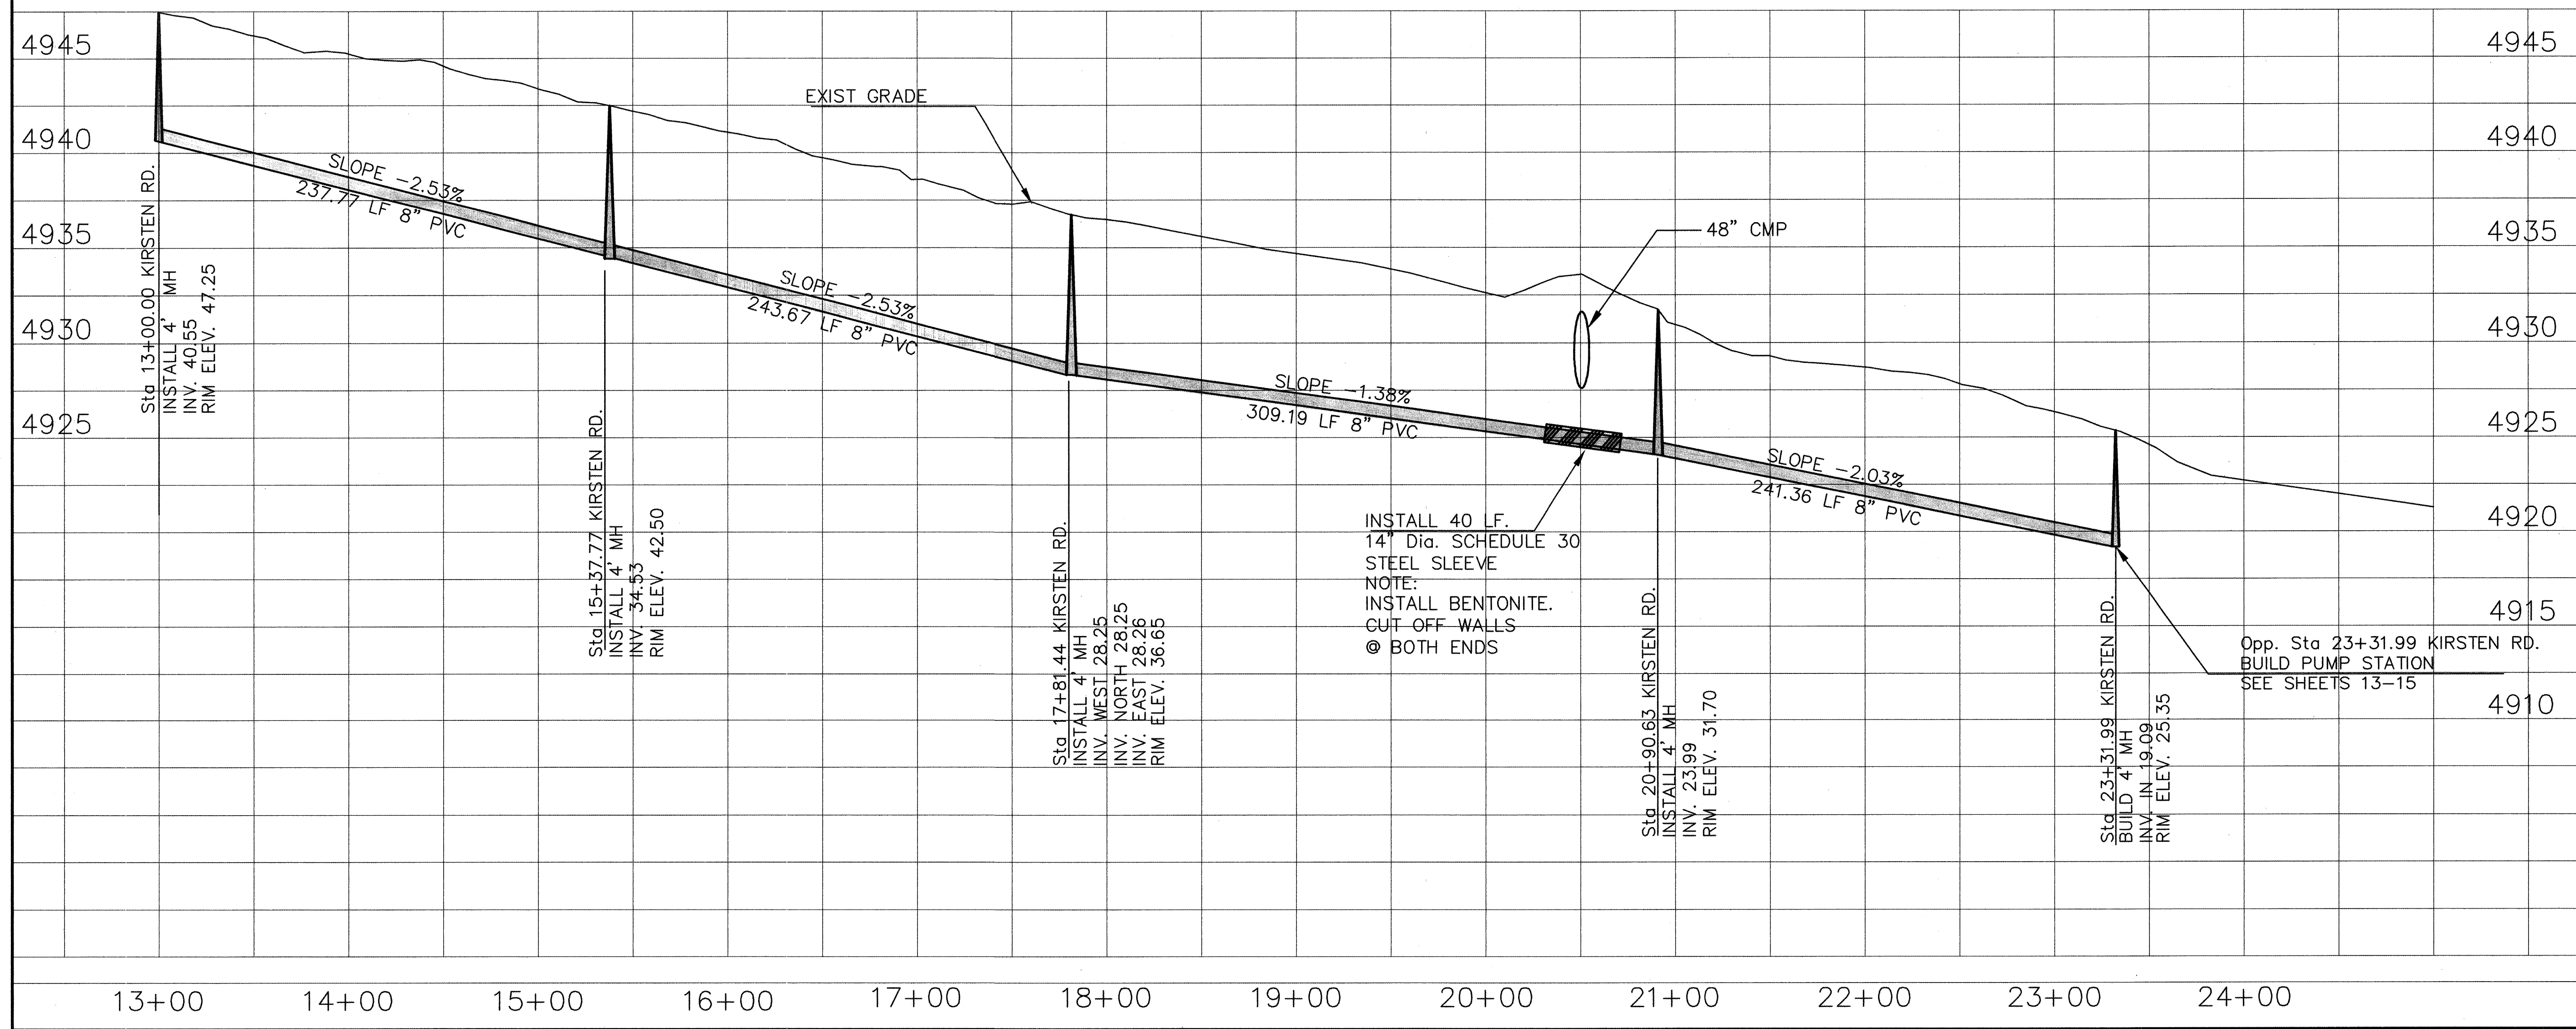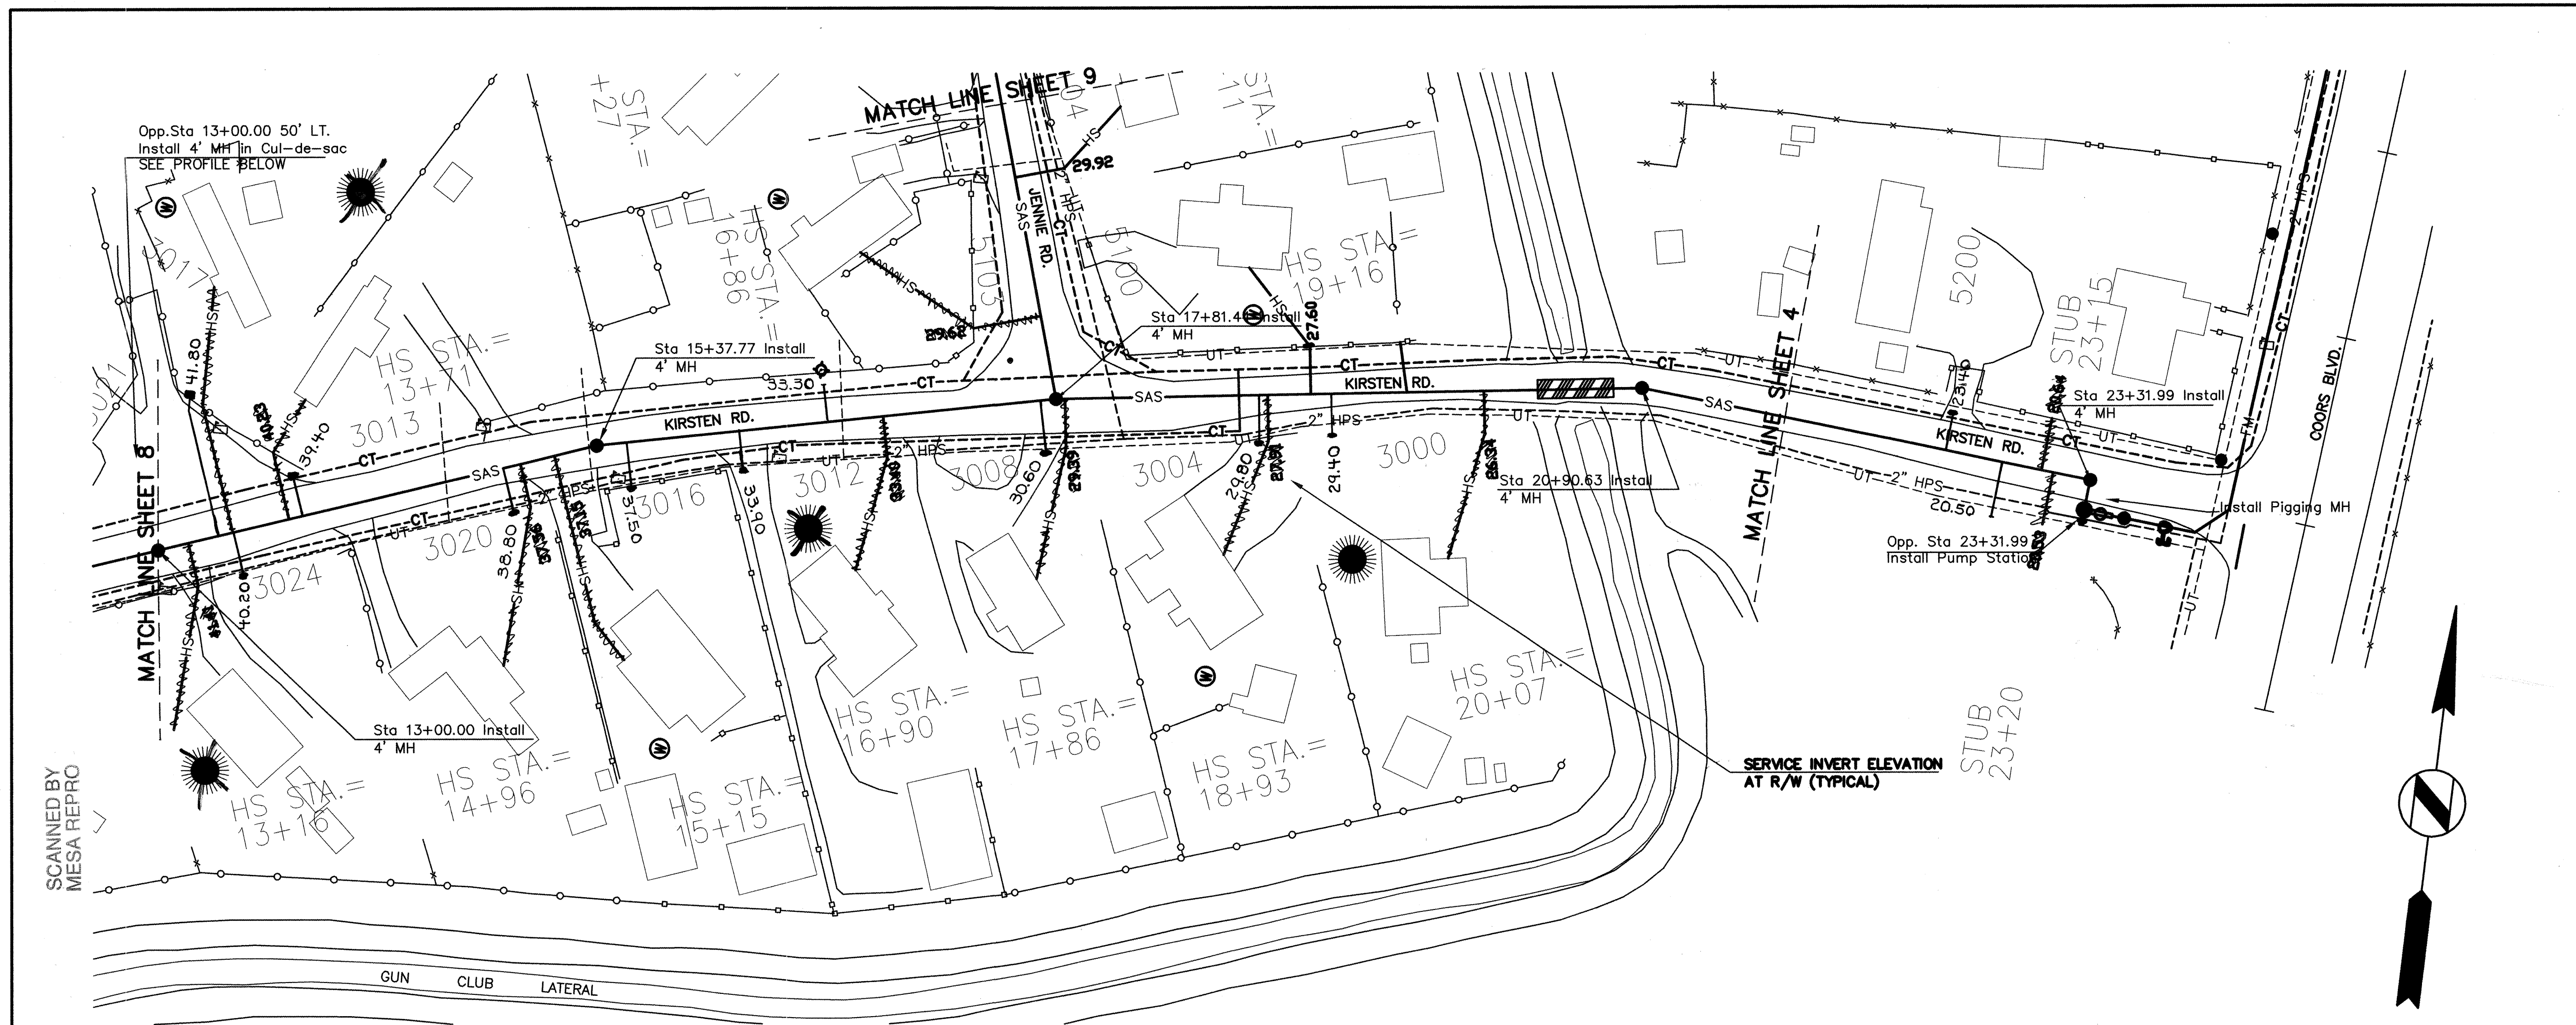

PLAN
SCALE: 1"=50'

PROFILE
SCALE: 1"=50' HOR
1"=5' VERT

LEGEND

NEW	EXIST.	
FM	FM	FORCE MAIN
SAS	SAS	SANITARY SEWER LINE
HS	HS	SAS HOUSE SERVICE
	MANHOLE	MANHOLE
	CT	CATV
	2" HPS	2" GAS LINE
	6" HPS	6" GAS LINE
	UT	UNDERGROUND TELEPHONE LINE
	UE	UNDERGROUND ELECTRICAL LINE
		OVERHEAD POWER POLE W/ GUY WIRE
		WELL

AS BUILT INFORMATION

CONTRACTOR	CONCOR CONST	DATE	1998
DESIGNED BY	BZ	DATE	1998
DRAWN BY	GRH	DATE	1998
CHECKED BY	JL	DATE	1998
RECORDED BY		DATE	

BENCH MARKS

7-101, City of Albuquerque bench mark, the station is a standard ACS 3 1/4" aluminum cap riveted to a pipe 0.25' above ground and is stamped "7-101, 1988".

Station is located at intersection of Gun Club and Kirk Line on the north side of intersection.

SCANNED BY
MESA REPRO

ENGINEER'S SEAL

WILLIAM F. ZIMMERMAN
REGISTERED PROFESSIONAL ENGINEER
07/31/98

"AS RECORDED"

From information provided by the contractors

By *[Signature]* Date *12/19/98*

HDR
HDR Engineering, Inc.

BERNALILLO COUNTY
PUBLIC WORKS DEPARTMENT


TITLE: COORS PARK AND DESERT PALMS
SEWER PROJECT

Design Review Committee	City Engineer Approval	Mr. [Signature]	Mr. [Signature]

PROJECT NO. 5737.90


FILE NAME BC_07

SHEET 7 OF 16

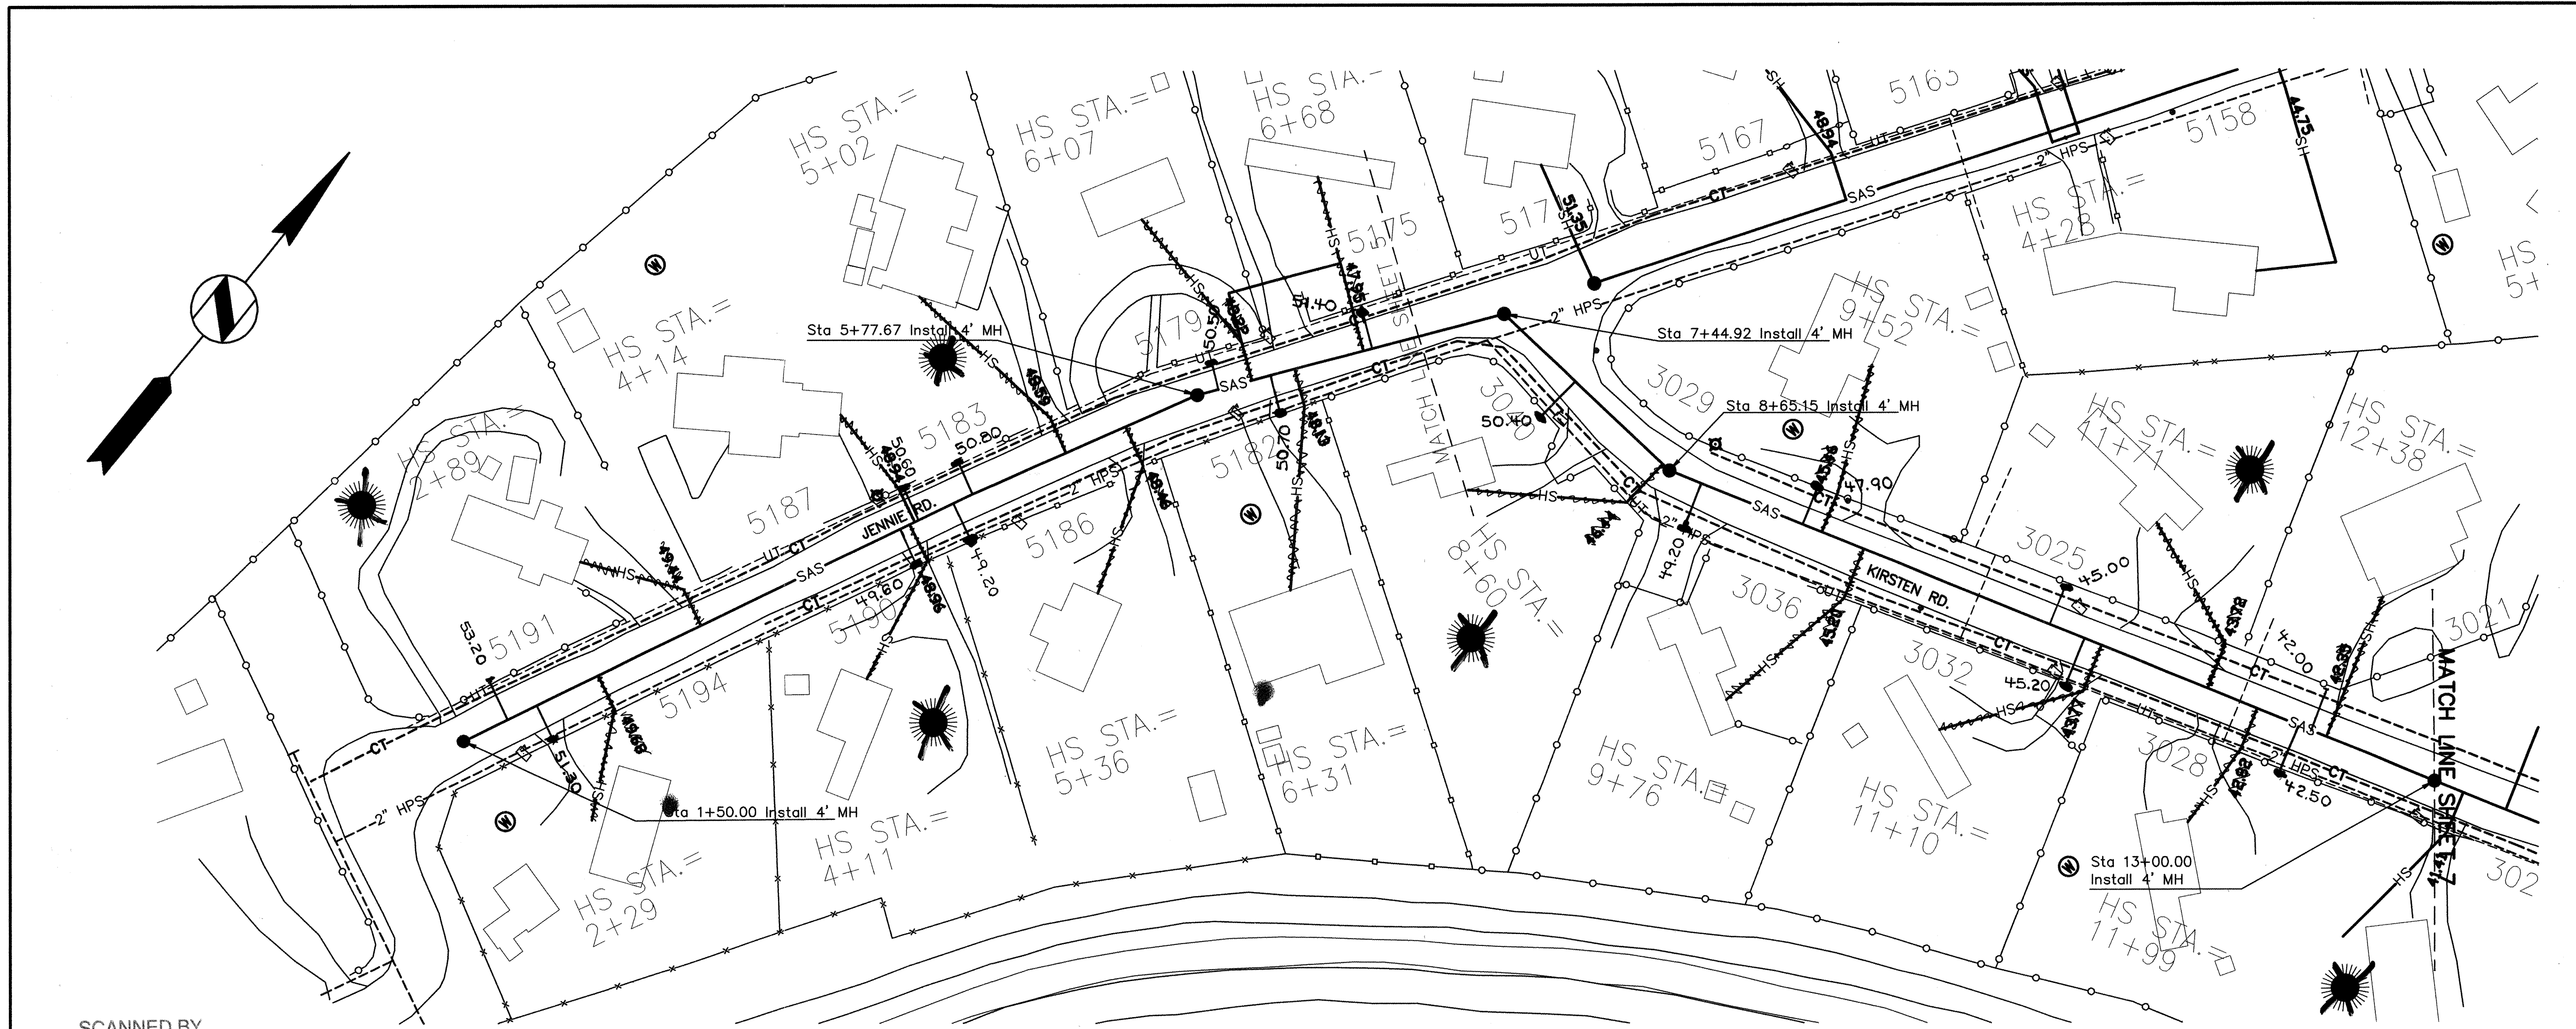

SCANNED BY
MESA REPRO

JENNIE RD. / KIRSTEN RD.

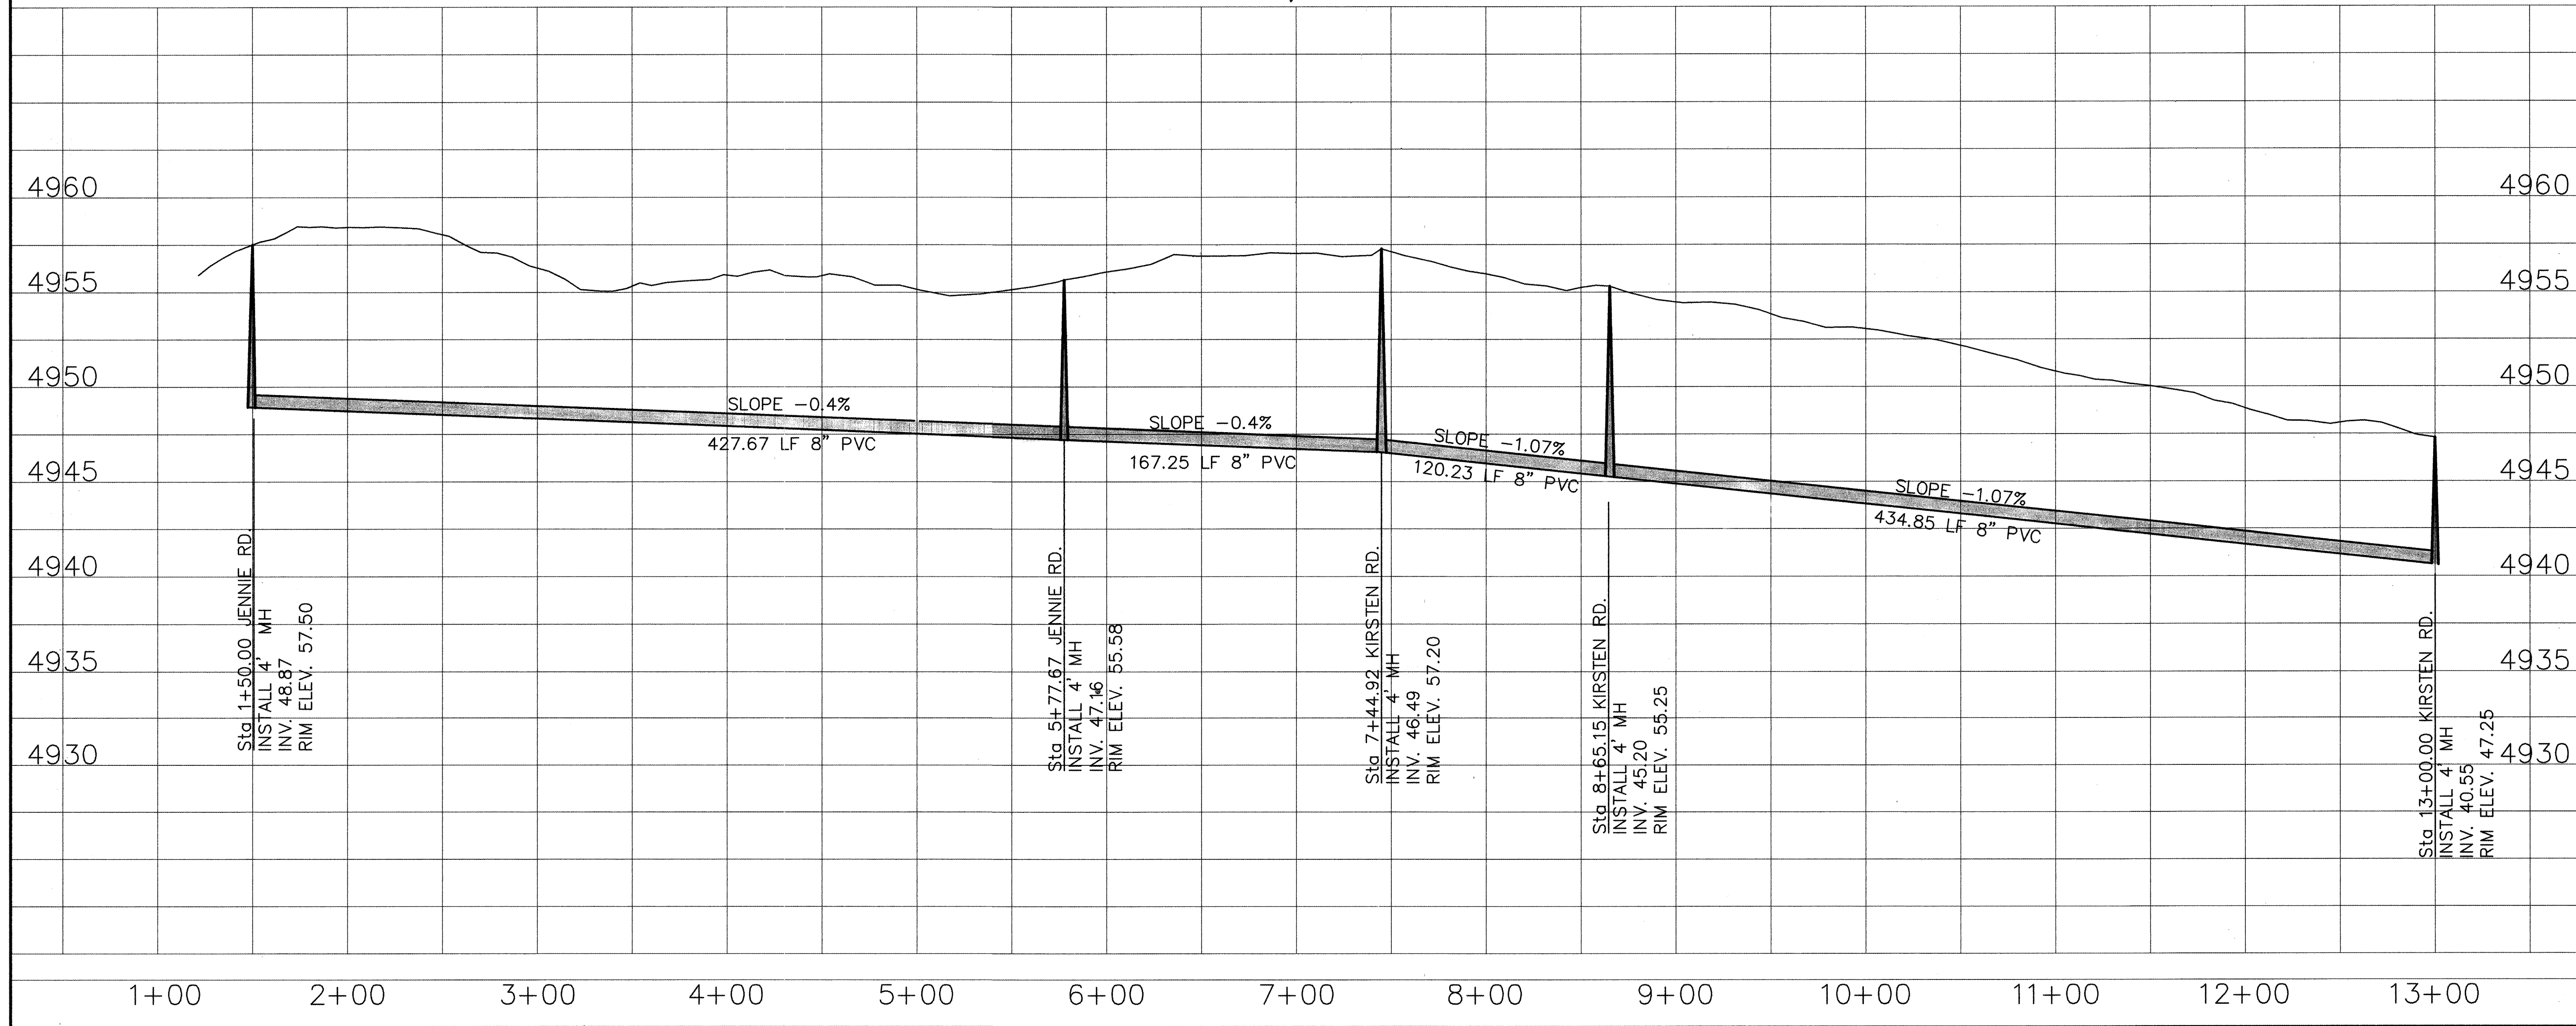

PLAN
SCALE: 1"=50'

PROFILE
SCALE: 1"=50' HOR
1"=5' VERT

- LEGEND**
- NEW EXIST.
- FM FM FORCE MAIN
- SAS SAS SANITARY SEWER LINE
- HS HS SAS HOUSE SERVICE
- MANHOLE
- CT CATV
- 2" HPS 2" GAS LINE
- 6" HPS 6" GAS LINE
- UT UNDERGROUND TELEPHONE LINE
- SEPTIC TANK
- UE UNDERGROUND ELECTRICAL LINE
- OVERHEAD POWER POLE W/ GUY WIRE
- WELL

AS BUILT INFORMATION			
CONTRACTOR	CONTRACT NO.	DATE	1998
STARTED BY	DATE	1998	
ACCEPTANCE BY	DATE	1998	
DRAWINGS	DATE	1998	
CORRECTED BY	DATE	1998	
RECORDED BY	DATE		
NO.			

BENCH MARKS			
7-010, City of Albuquerque bench mark, the station is a standard 7-010, 1988	DATE		
aluminum cap riveted to a pipe 0.25' above ground and is stamped 7-010, 1988	BY		
Station is located at intersection of Sun Club and Kirk Line on the north side of intersection.	NO.		

SURVEY INFORMATION			
FIELD NOTES	DATE		
BY			
NO.			

ENGINEER'S SEAL			
DATE	REVISIONS	BY	
DESIGNED BY BZ	DATE 2/1998		
DRAWN BY GRH	DATE 2/1998		
CHECKED BY JL	DATE 2/1998		

"AS RECORDED"

From information provided by the contractors

By DS Date 12/1/98

HDR

HDR Engineering, Inc.

BERNALILLO COUNTY
PUBLIC WORKS DEPARTMENT


TITLE: COORS PARK AND DESERT PALMS SEWER PROJECT
KIRSTEN ROAD

Design Review Committee	City Engineer Approval	10/20/98	10/20/98

PROJECT NO. 5737.90	FILE NAME BC_08	SHEET 8 OF 16
---------------------	-----------------	---------------

NOTES:

1. S.A.L. NOT TO BE LOCATED IN DRAINAGE PATHS. (i.e. SWALES, GUTTERS OR INVERTS, ETC.). LOCAL DRAINAGE TO BE DIRECTED AWAY FROM S.A.L. IN SHOULDER LOCATIONS.
2. ELECTRICAL POWER AND SUPPLY METERING TO BE COORDINATED WITH PUBLIC SERVICE COMPANY OF NEW MEXICO.
3. REFERENCE POINT: INTERSECTION OF COORS BLVD. AND KIRSTEN RD.
1456519.16 NORTH, 360172.96 EAST
EQUALS STA. 1+00 ALONG COORS BLVD.
BEARING N07°00'30"E EQUALS
STA. 24+45.79 ALONG KIRSTEN RD.
BEARING S84°05'41"E

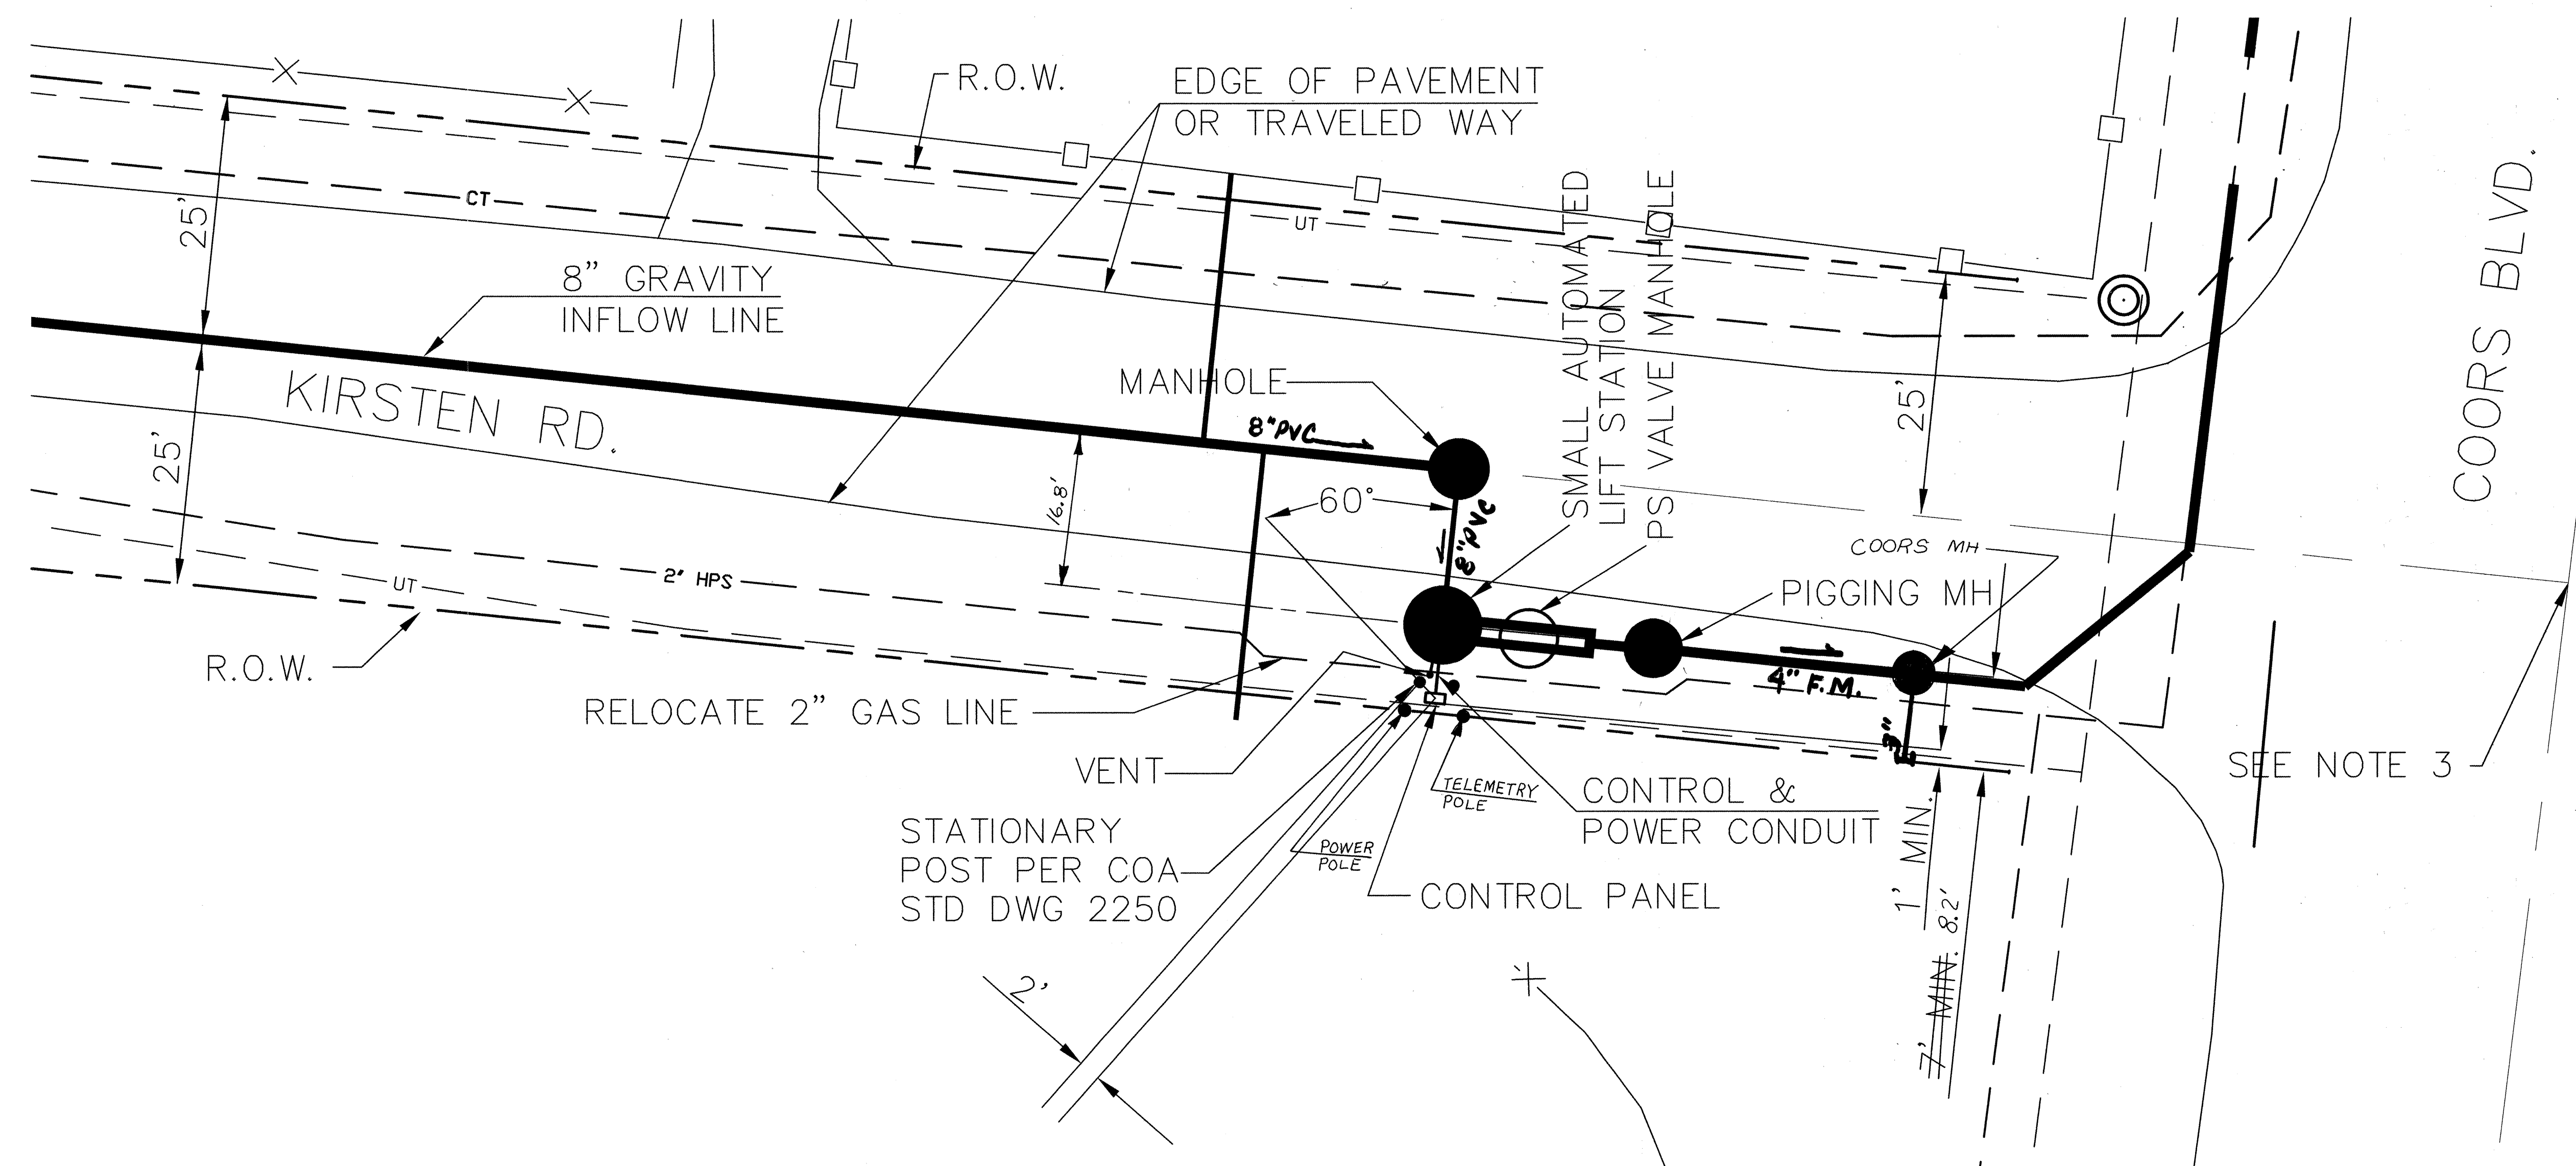

"AS RECORDED"
From information
provided by the
contractors
By DS Date 12/9/98


PUMP STATION DETAIL
SCALE: 1" = 10'

REVISIONS

CITY OF ALBUQUERQUE
LAYOUT PLAN
Small Automatic Lift-station
DWG. S.A.L. - 2 OF 8 SEPT 1996

SAL_BC11.DWG


DWG 5737.90 11 OF 16

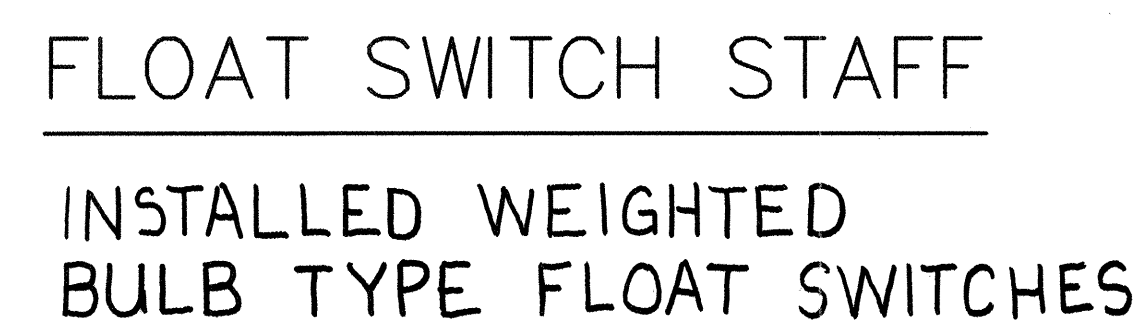

- SEE SHEET 4 OF 8 FOR CONSTRUCTION NOTES
SEE SHEET 4 OF 8 FOR CROSS SECTION A-A
SEE SHEET 4 OF 8 FOR CROSS SECTION B-B
SEE SHEET 4 OF 8 FOR CROSS SECTION C-C

PUMPS, PIPES AND ELECTRICAL
DETAILS NOT APPLICABLE.

	CITY OF ALBUQUERQUE
REVISIONS	WET WELL Small Automatic Lift-station DWG. S.A.L. — 3 OF 8
	SEPT 1996

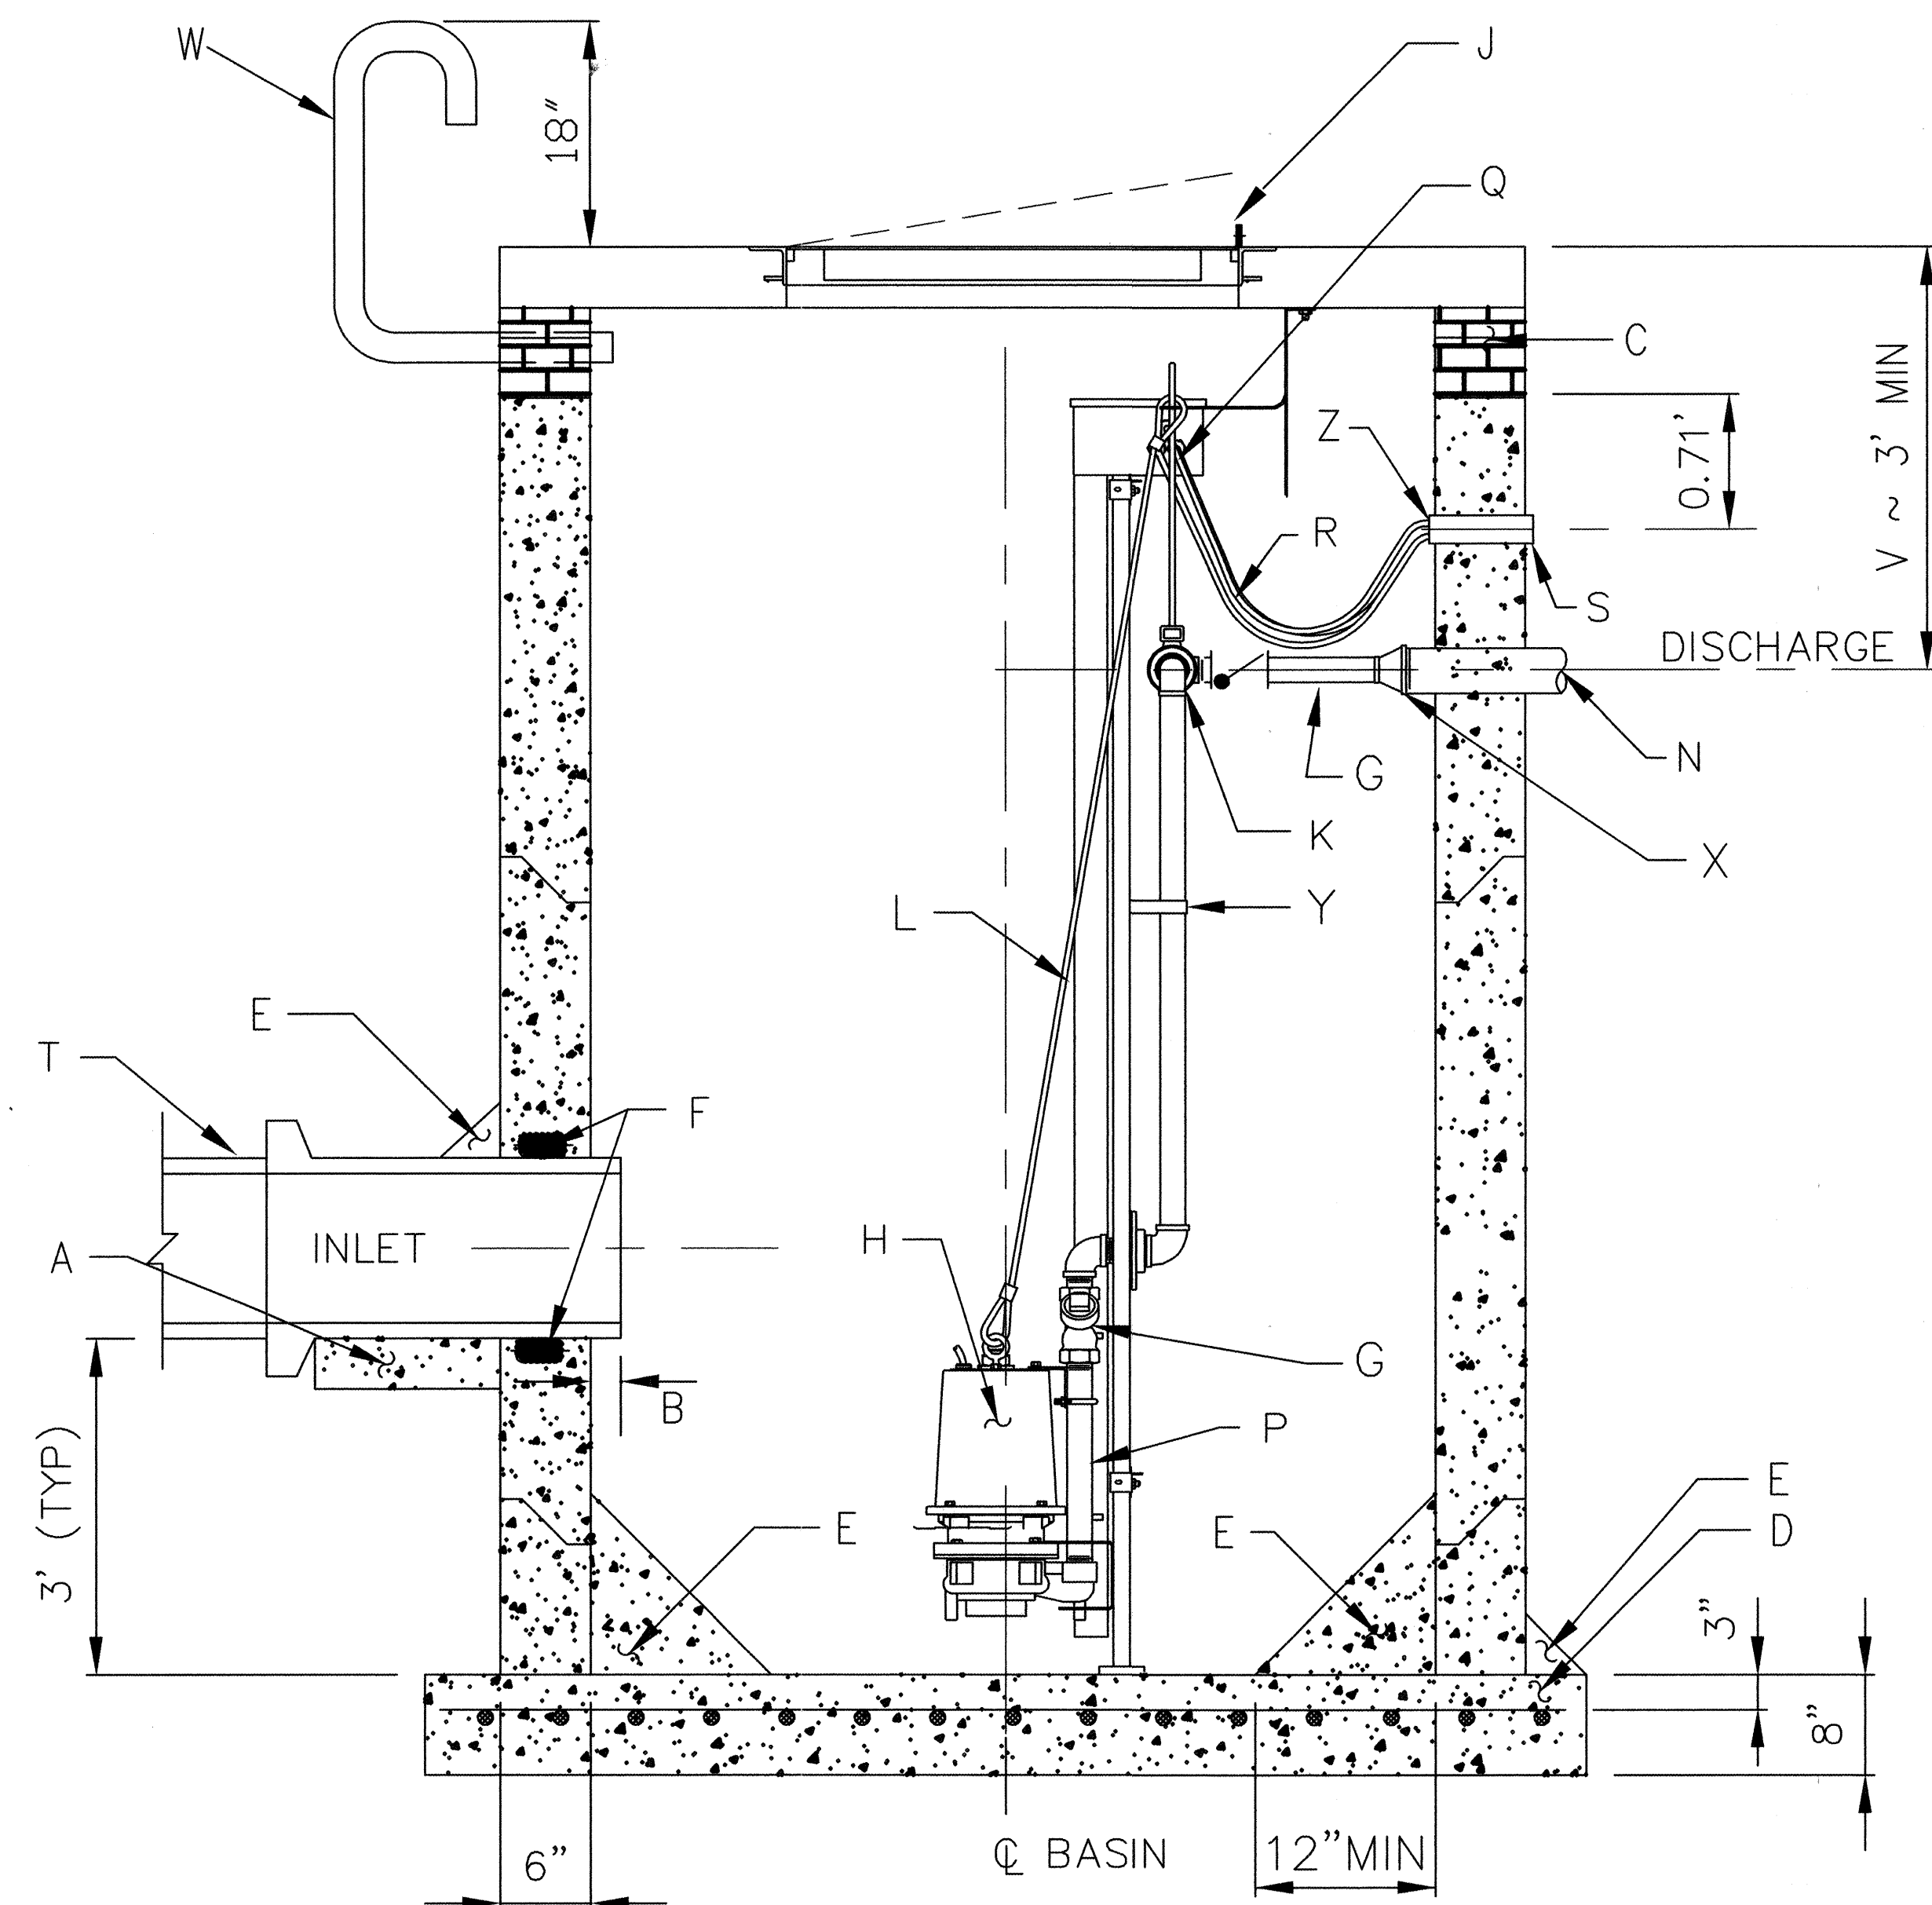


CROSS SECTION A-A

NTS


Location	Elevation
Top of Manhole	24.85
Inlet Invert	19.03
Top of Manhole Base	13.00
Invert of Discharge	18.00

NOTE:
ELECTRICAL JUNCTION BOXES TO BE INSTALLED
IN PUMP STATION MANHOLE.

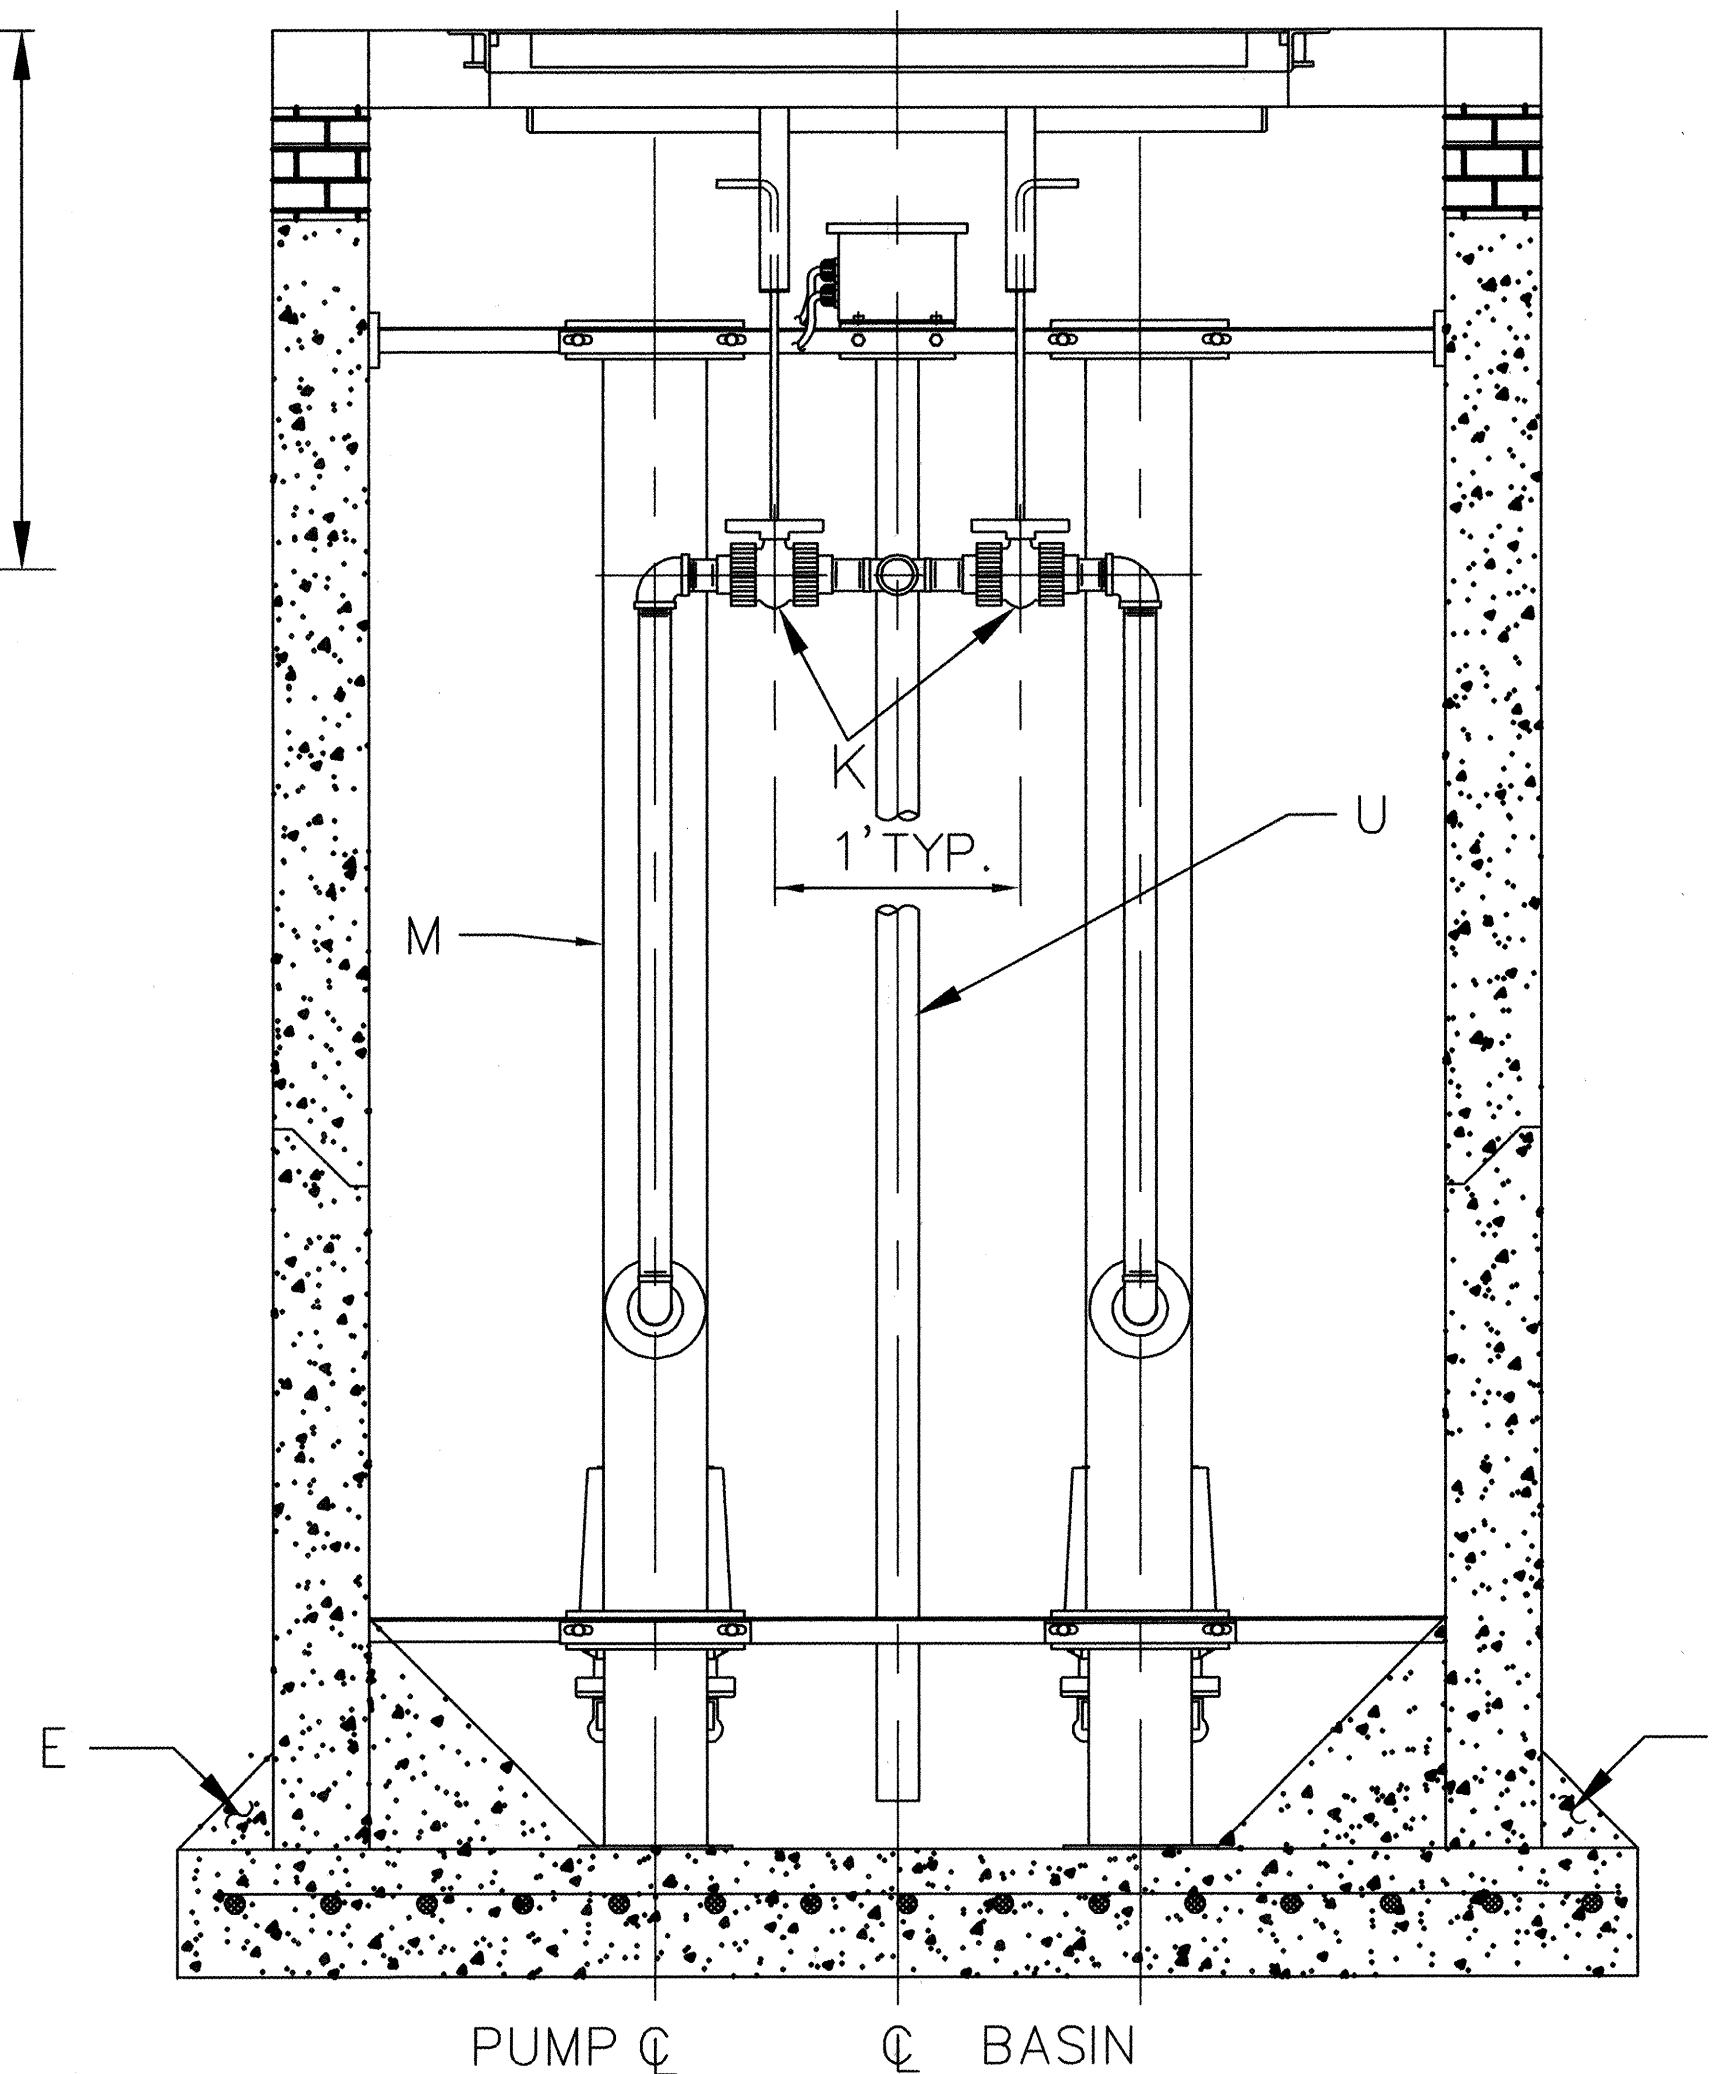


CROSS SECTION B-B

NTS

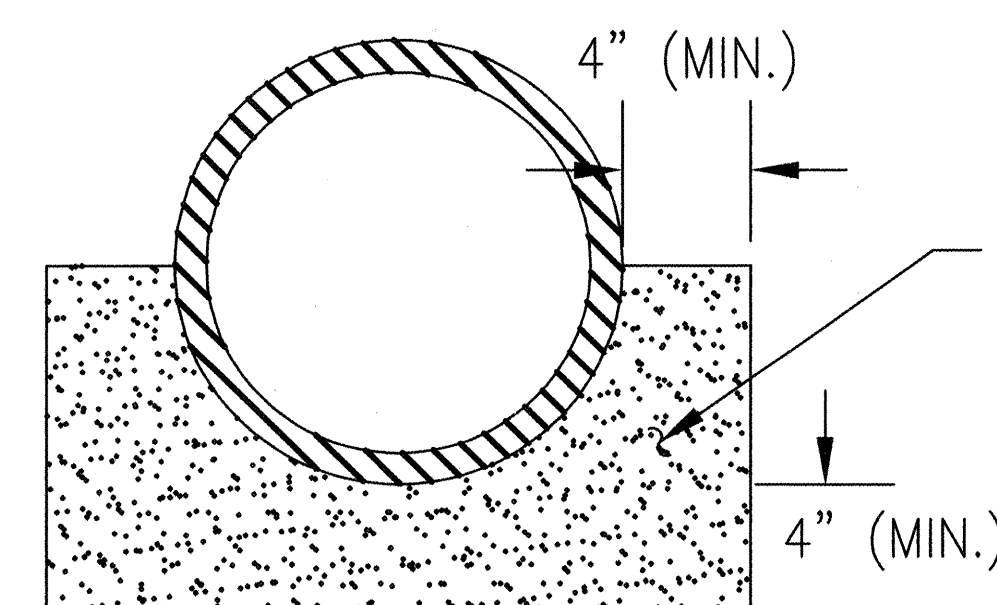

CROSS SECTION C-C

NTS

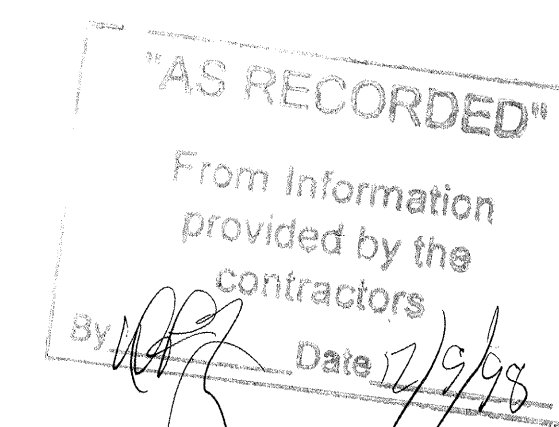

PUMPS, PIPES AND
ELECTRICAL DETAILS
NOT APPLICABLE.

CONSTRUCTION NOTES:

- CONCRETE PIPE SUPPORTS SHALL EXTEND OUTSIDE OF VAULT TO BELL OF FIRST JOINT AND SHALL CRADLE PIPE TO SPRING LINE.
- PIPE PENETRATION INTO VAULT SHALL BE FLUSH TO 2" MAX., MEASURED AT SPRINGLINE OF PIPE.
- FRAME TO BE ADJUSTED WITH GR. MS BRICKS AS NECESSARY. PLASTER INSIDE WITH 1/2" MORTAR.
- BASE TO BE POURED IN PLACE USING NO. 4 BARS AT 6" O.C. EA. WAY FOR VAULT DEPTH OF 16' OR GREATER. NO. 4 BARS AT 12" O.C. EA. WAY FOR VAULT LESS THAN 16' DEEP.
- 6" GROUT FILLET ON UPPER HALF OF PIPE AND AROUND BASE, INSIDE AND OUT. (2:1 MIN)
- APPROVED WATERSTOP. SEE DETAIL SHEET 3 OF 8.
- 1-1/4" BALL CHECK VALVE. (QTY. 2)
- GRINDER PUMP ON GUIDE RAIL SYSTEM WITH LIFTING ROPE, POWER CABLE AND ALARM SYSTEM.
- VAULT LID WITH FRAME. SEE SHEET 5 OF 8.
- 1-1/4" NPT PVC BALL VALVE WITH TRUE UNION JOINTS.
- POLYPROPYLENE LIFTING ROPE.
- GUIDE BARS AND FRAME FOR PUMP REMOVAL (BOLT PATTERN CAST IN PLACE PER PUMP MANUFACTURER).
- DR21 PVC DISCHARGE PIPE (SIZE VARIES).
- CONCRETE COVER IN SHOULDER AREAS. USE CAST IRON LID AND FRAME IN TRAVELED WAY, SEE SHEET 5 OF 8.
- 1-1/4" NPT STAINLESS STEEL DISCHARGE PIPING INCLUDING NIPPLES AND ELBOW.
- STAINLESS STEEL EXTENSION HANDLES, OPEN POSITION SHOWN. (QTY. 2)
- DIRECT BURIAL CABLE.
- 1-1/2" ELEC. CONDUIT SLEEVE.
- 8" PVC INLET PIPE.
- REMOVEABLE FLOAT SWITCH STAFF. SEE SHEET 3 OF 8.
- DEPTH TO SURFACE AS SHOWN ON PLANS
- SCREENED VENT - 2" GALVANIZED PIPE.
- ENLARGER - REVERSED REDUCER FITTING
- BRACE
- CAULK WITH SILICONE

REVISIONS


CITY OF ALBUQUERQUE

WET WELL
Small Automatic Lift-station


DWG. S.A.L. - 4 OF 8 SEPT 1996

SAL_BC13.DWG **5737.90**


13 OF 16

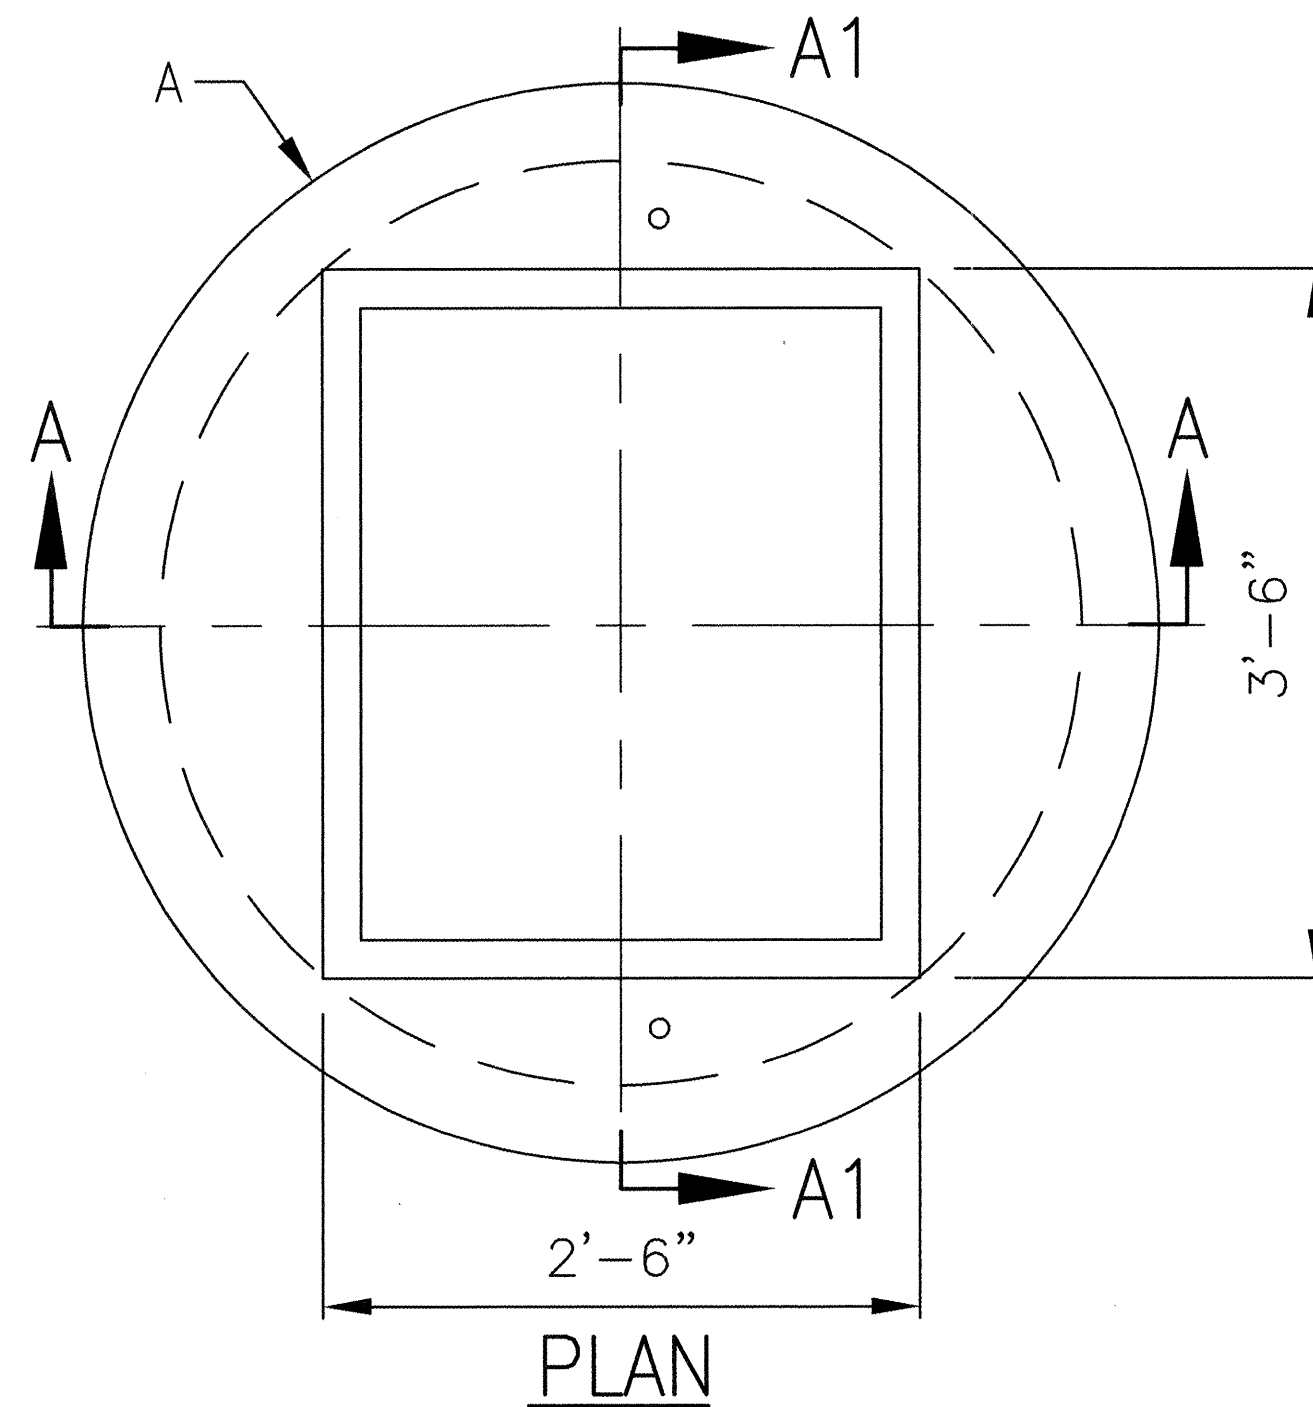


PLAN

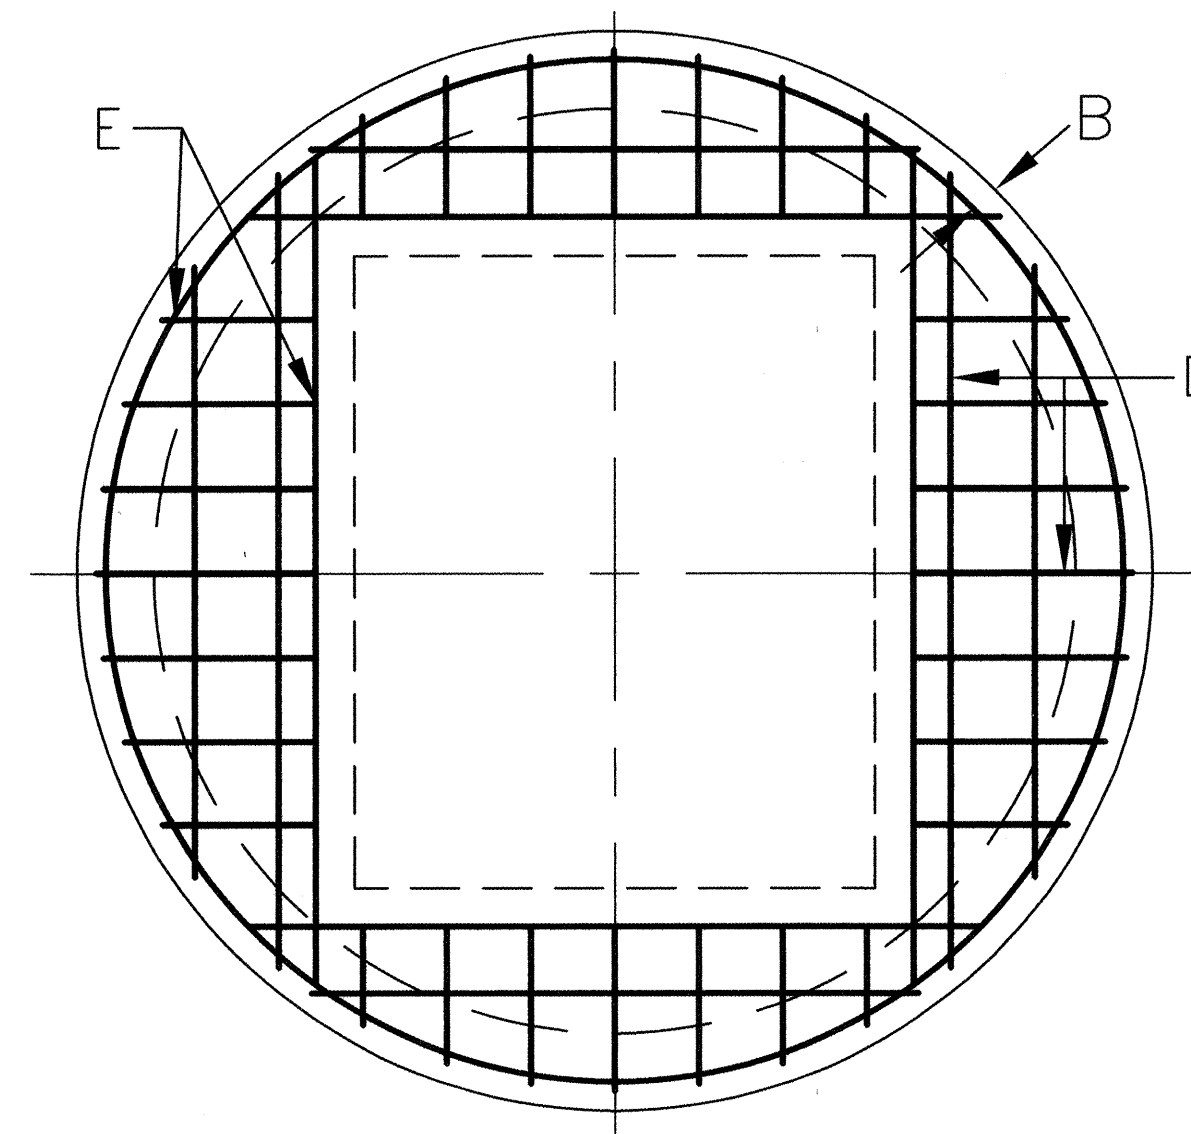


SECTION B-B, TOP MAT

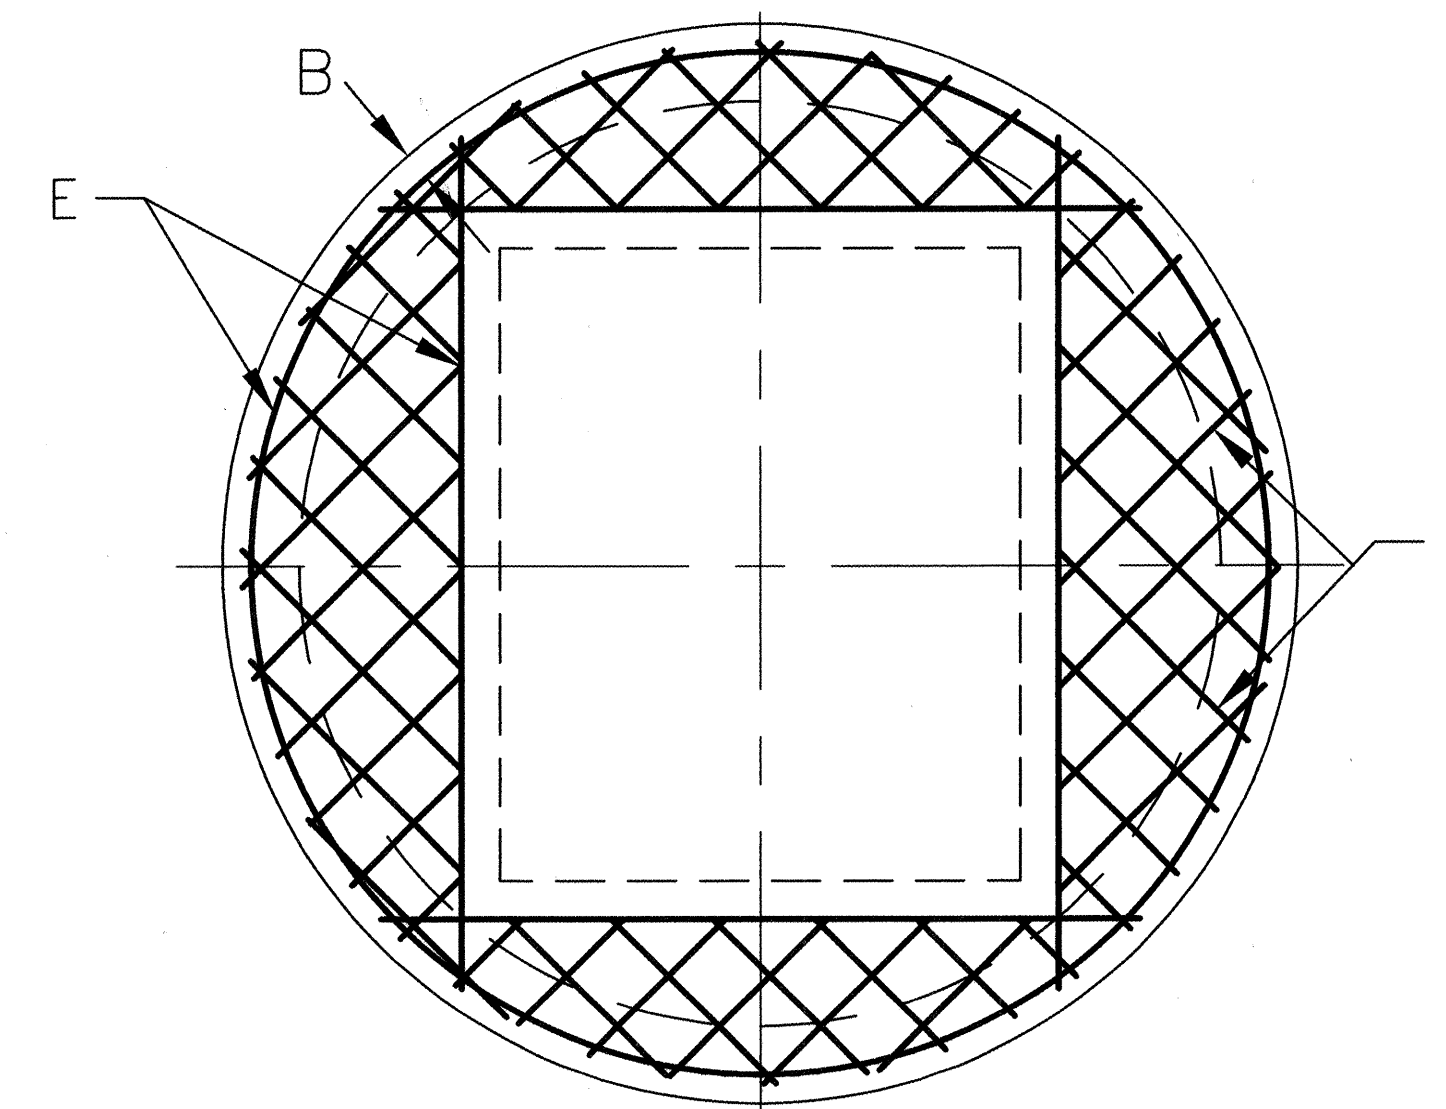

SECTION C-C, BOTTOM MAT

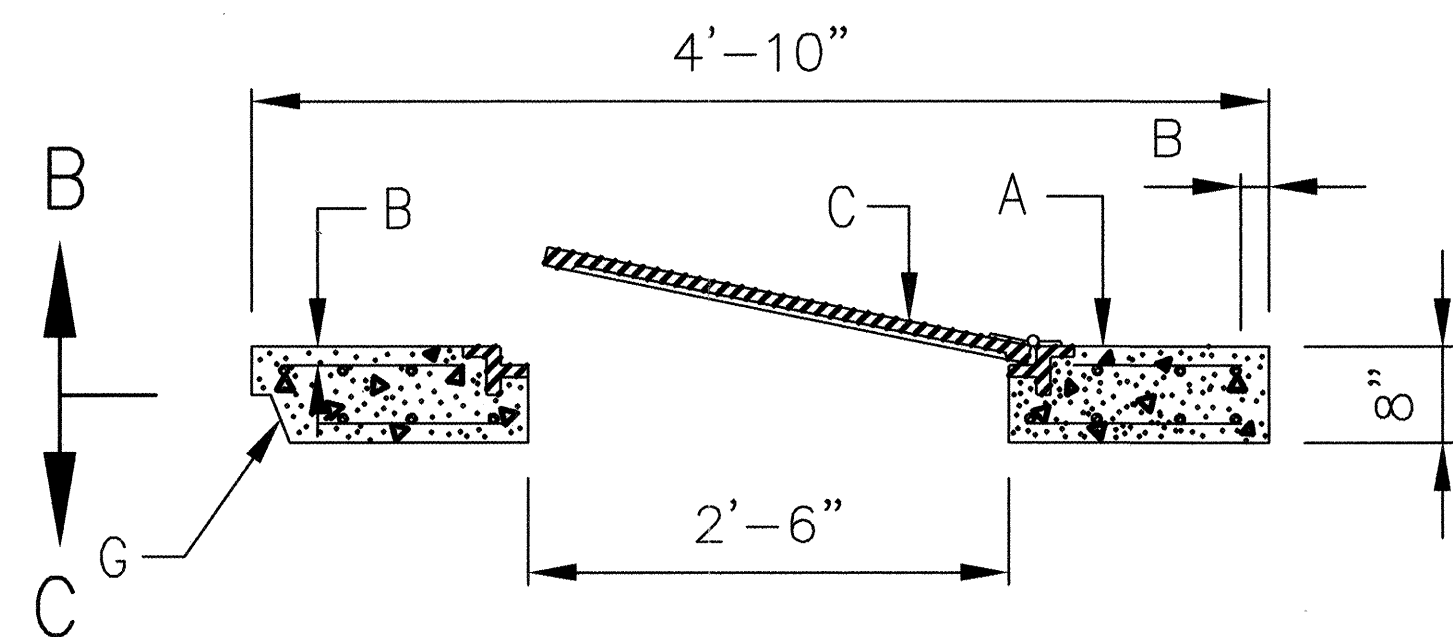


SECTION A-A

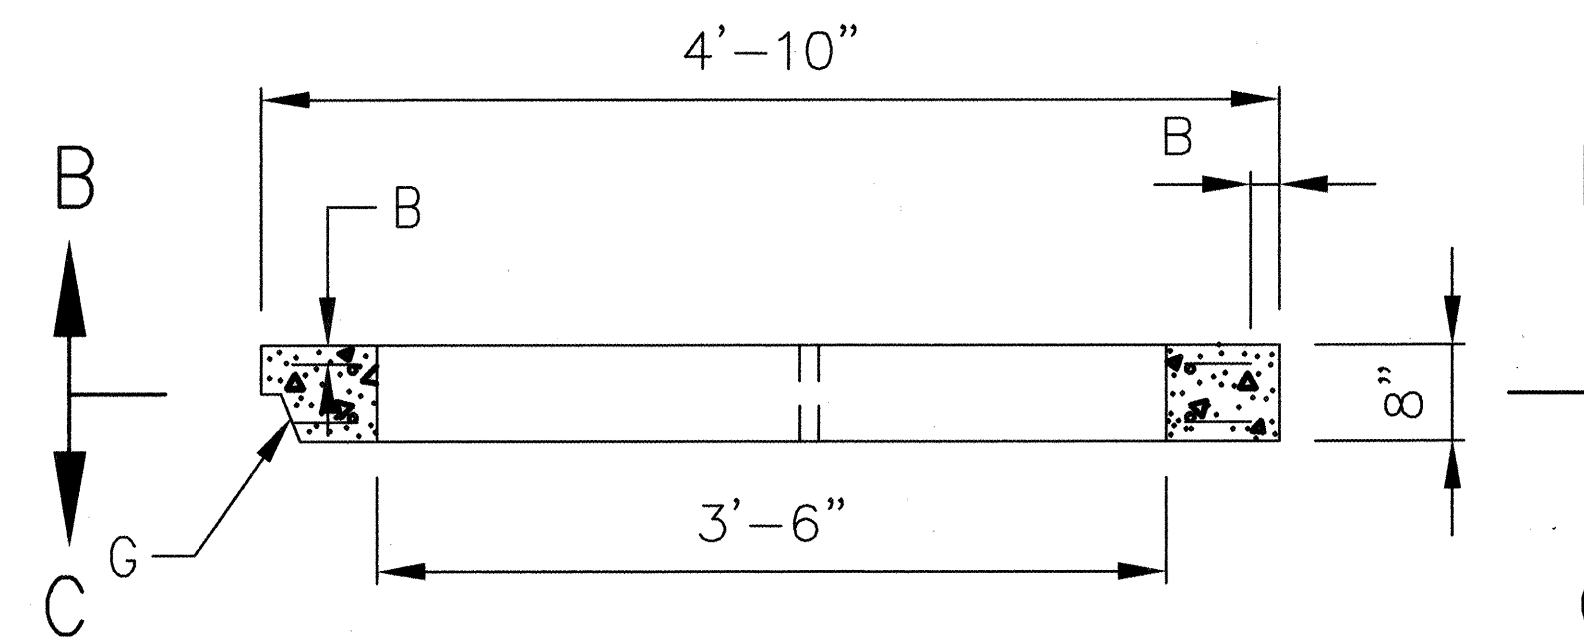


SECTION A1-A1

SHOULDER

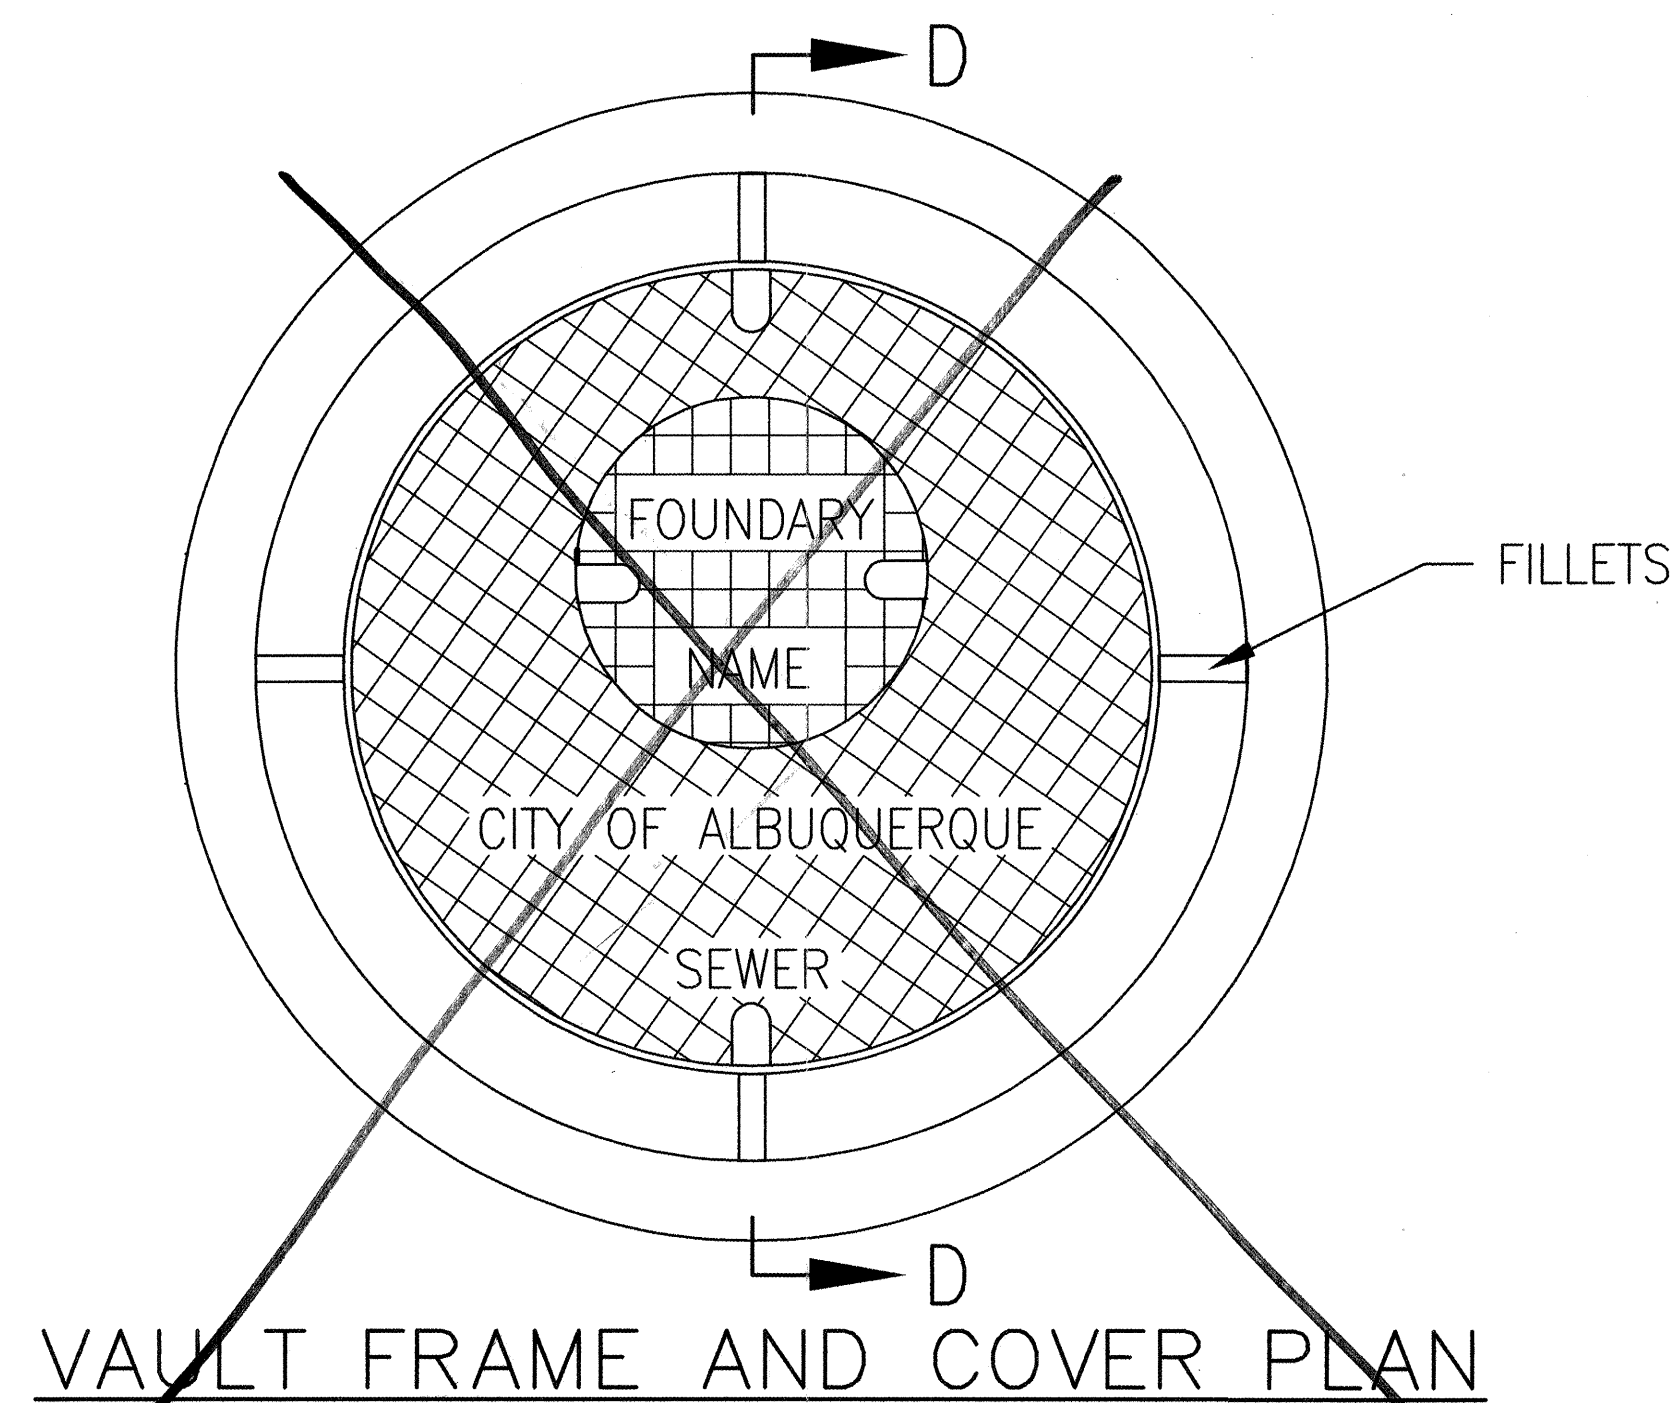

VAULT FRAME AND COVER PLAN

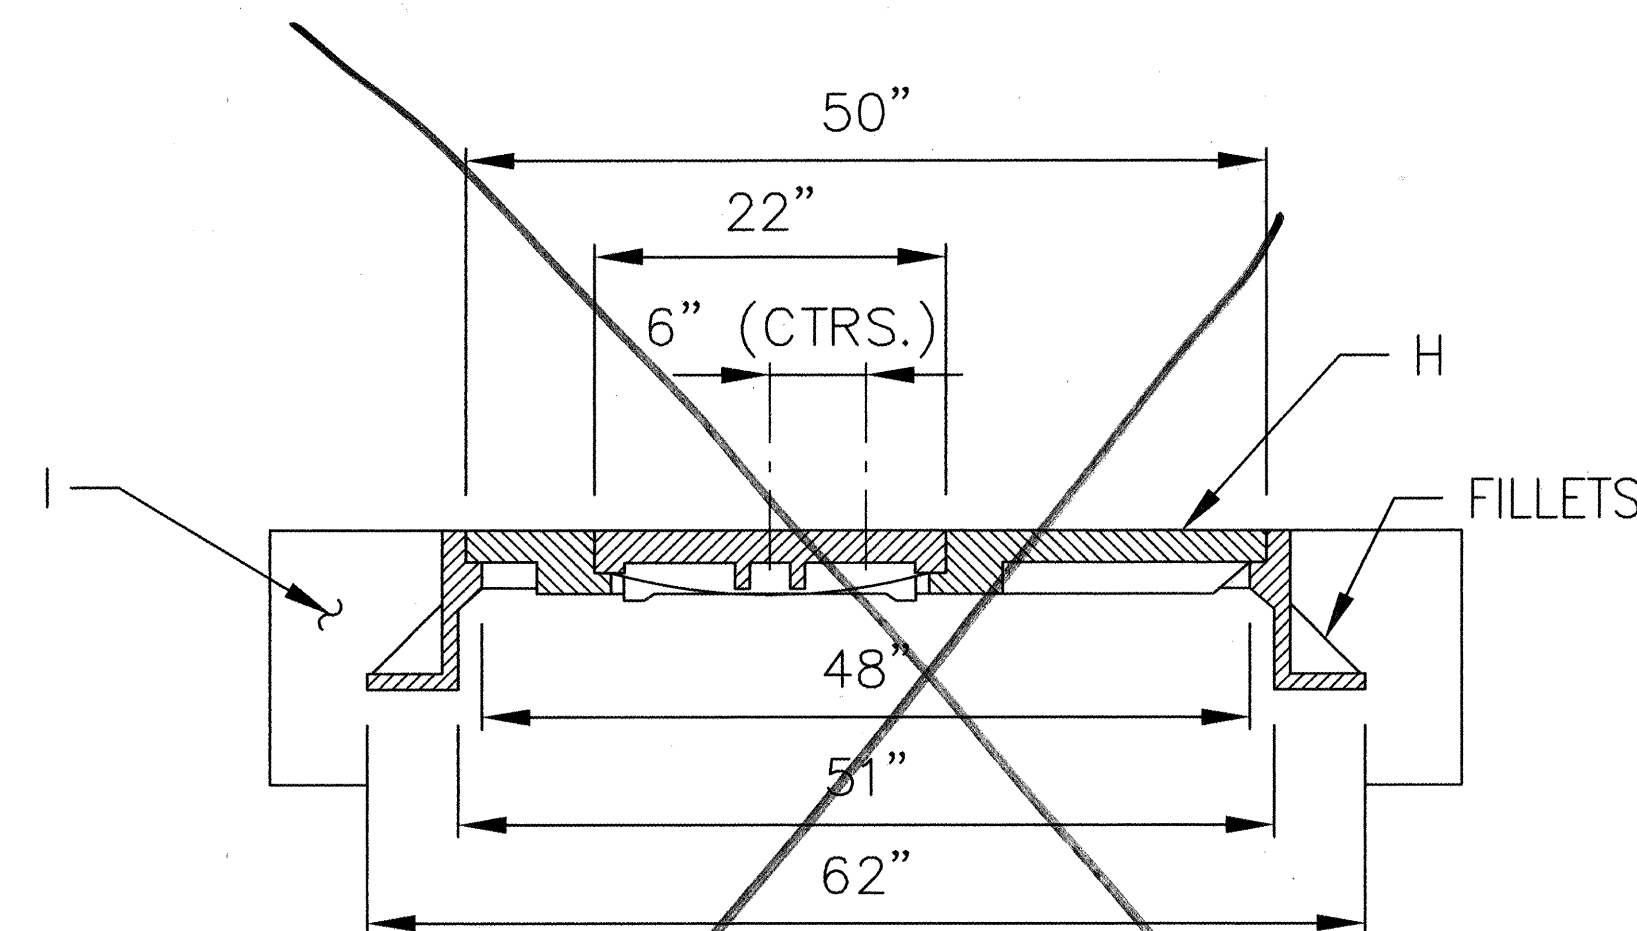


CROSS SECTION D-D

TRAVELED-WAY

CONSTRUCTION NOTES:

- A. PRECAST REINF. CONC. MH COVER.
- B. ALL BARS TO HAVE 1 1/2" MIN. COVER.
- C. RECTANGULAR SLAB TYPE MANHOLE FRAMES WITH BOLTED, GASKET-SEALED LIDS. NEENAH R-6665-3JH HEAVY DUTY OR EQUIVALENT.
- D. TOP MAT NO. 4 BARS AT 6" O.C. EA. WAY
- E. NO. 4 BARS.
- F. BOTTOM MAT NO. 4 BARS 6" O.C. EA. WAY
- G. WHEN PRECAST M.H. SECTIONS ARE USED, COVER SHALL BE MODIFIED TO SHAPE OF APPROPRIATE SIZE T & G JOINT.
- H. VAULT LID WITH FRAME (NEENAH R-1741-F OR EQUAL).
- I. 5' x 5' CONCRETE PAD IN ALL AREAS, PAVED OR UNPAVED.

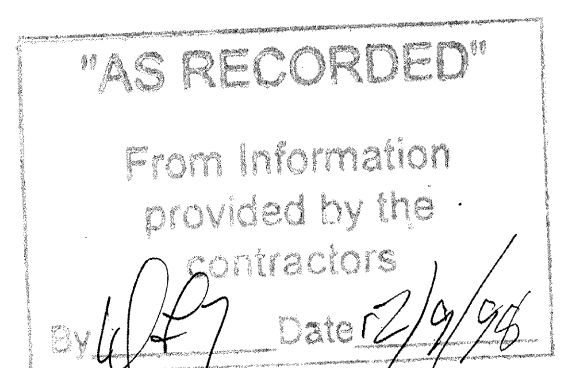

SQUARE ACCESS LID MAY BE USED WHEN LIFT STATION IS CONSTRUCTED IN SHOULDER OR BEHIND CURB.

CIRCULAR ACCESS LID MAY BE USED WHEN LIFT STATION IS CONSTRUCTED IN TRAVELED-WAY OR SHOULDER.

REVISIONS

CITY OF ALBUQUERQUE

LIDS AND FRAMES
Small Automatic Lift-station

DWG. S.A.L. - 5 OF 8 SEPT 1996

SAL_BC13.DWG 5737.90

14 OF 16

