


CITY OF ALBUQUERQUE CONSOLIDATED RENTAL CAR FACILITY SIGNAGE

ALBUQUERQUE INTERNATIONAL SUNPORT
ALBUQUERQUE, NEW MEXICO

CITY PROJECT NUMBER: 6101.98
ARCHITECTS PROJECT NUMBER: 98096
DATE: JUNE 01, 2000

INDEX OF DRAWINGS

GENERAL INFORMATION	
G1.0	COVER SHEET/SHEET INDEX
CIVIL	
C1.0	OVERALL TRAFFIC SIGNING/STRIPING PLAN
C1.1	STRIPING AND SIGNAGE AREA "A"
C1.2	STRIPING AND SIGNAGE AREA "B"
C1.3	STRIPING AND SIGNAGE AREA "C"
C1.4	STRIPING AND SIGNAGE AREA "D"
C1.5	STRIPING AND SIGNAGE AREA "E"
C1.6	STRIPING AND SIGNAGE AREA "F"
C5.1	SIGN DETAILS
ELECTRICAL	
ES.1	SIGN LIGHTING PLAN - OVERALL
ES.2	SIGN LIGHTING PLAN - MAIN ENTRANCE

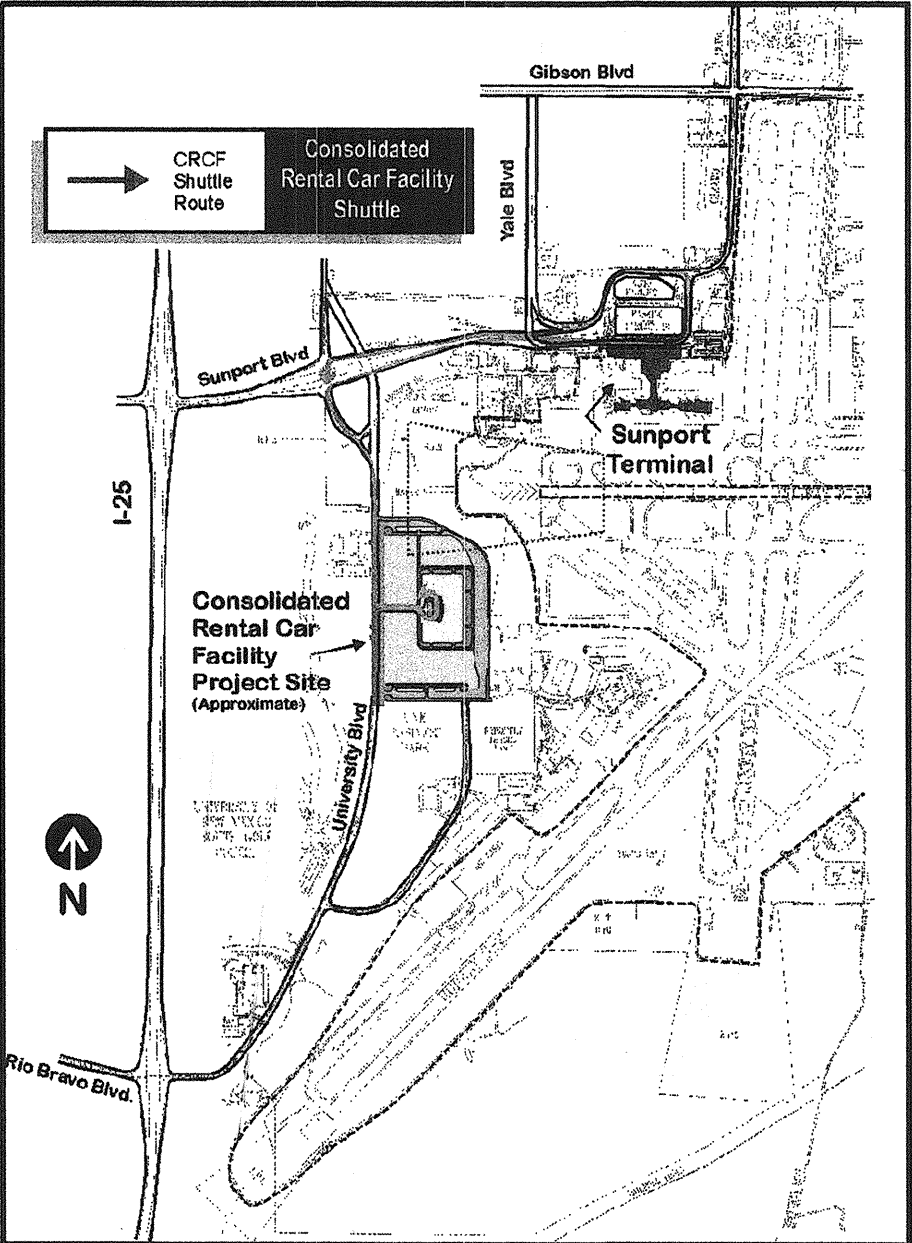

VICINITY MAP

NOTICE TO CONTRACTORS

- ALL WORK DETAILED ON THESE PLANS TO BE PERFORMED UNDER CONTRACT SHALL, EXCEPT AS OTHERWISE STATED OR PROVIDED FOR HEREON, BE CONSTRUCTED IN ACCORDANCE WITH THE CITY OF ALBUQUERQUE STANDARD SPECIFICATIONS FOR PUBLIC WORKS CONSTRUCTION, 1986 EDITION, AS AMENDED THROUGH UPDATE #6.
- TWO WORKING DAYS PRIOR TO ANY EXCAVATION, THE CONTRACTOR MUST CONTACT NEW MEXICO ONE CALL SYSTEM (260-1990) FOR LOCATION OF EXISTING UTILITIES.
- PRIOR TO CONSTRUCTION, THE CONTRACTOR SHALL EXCAVATE AND VERIFY THE HORIZONTAL AND VERTICAL LOCATIONS OF ALL OBSTRUCTIONS. SHOULD A CONFLICT EXIST, THE CONTRACTOR SHALL NOTIFY THE ENGINEER OR SURVEYOR IMMEDIATELY SO THAT THE CONFLICT CAN BE RESOLVED WITH A MINIMUM AMOUNT OF DELAY.
- FIVE (5) WORKING DAYS PRIOR TO BEGINNING CONSTRUCTION, THE CONTRACTOR SHALL SUBMIT TO CONSTRUCTION COORDINATION DIVISION A DETAILED CONSTRUCTION SCHEDULE. TWO (2) WORKING DAYS PRIOR TO CONSTRUCTION, THE CONTRACTOR SHALL OBTAIN A BARRICADING PERMIT FROM THE CONST. COORDINATION DIVISION. CONTRACTOR SHALL NOTIFY BARRICADE ENGINEER (768-2551) PRIOR TO OCCUPYING AN INTERSECTION. REFER TO SECTION 19 OF THE GENERAL CONDITIONS OF THE STANDARD SPECIFICATIONS.
- CONTRACTOR SHALL NOTIFY THE ENGINEER NOT LESS THAN SEVEN (7) DAYS PRIOR TO STARTING WORK IN ORDER THAT THE ENGINEER MAY TAKE NECESSARY MEASURES TO INSURE THE PRESERVATION OF SURVEY MONUMENTS. CONTRACTOR SHALL NOT DISTURB PERMANENT SURVEY MONUMENTS WITHOUT THE CONSENT OF THE ENGINEER AND SHALL NOTIFY THE ENGINEER AND BEAR THE EXPENSE OF REPLACING ANY MONUMENT THAT MAY BE DISTURBED WITHOUT PERMISSION. REPLACEMENT SHALL BE DONE ONLY BY THE CITY SURVEY SECTION. WHEN A CHANGE IS MADE IN THE FINISHED ELEVATIONS OF THE PAVEMENT OF ANY ROADWAY IN WHICH A PERMANENT SURVEY MONUMENT IS LOCATED, THE CONTRACTOR SHALL, AT HIS OWN EXPENSE, ADJUST THE MONUMENT COVER TO THE NEW GRADE UNLESS OTHERWISE SPECIFIED. REFER TO SECTION 4.4 OF THE GENERAL CONDITIONS OF THE STANDARD SPECIFICATIONS.
- ANY WORK AFFECTING AN ARTERIAL ROADWAY REQUIRES TWENTY-FOUR (24) HOUR CONSTRUCTION.

THE FOLLOWING NOTES ALSO APPLY WHEN CHECKED

- ☐ ALL UTILITIES AND UTILITY SERVICE LINES SHALL BE INSTALLED PRIOR TO PAVING.
- ☐ BACKFILL COMPACTION SHALL BE ACCORDING TO SPECIFIED STREET USE.
- ☐ TACK COAT REQUIREMENTS SHALL BE DETERMINED BY THE CITY ENGINEER.
- ☐ SIDEWALKS AND WHEELCHAIR RAMPS WITHIN THE CURB RETURNS SHALL BE CONSTRUCTED WHEREVER A NEW CURB RETURN IS CONSTRUCTED.
- ☐ IF CURB IS DEPRESSED FOR A DRIVEPAD, THE DRIVEPAD SHALL BE CONSTRUCTED PRIOR TO ACCEPTANCE OF CURB AND GUTTER.
- ☐ ALL STORM DRAINAGE FACILITIES SHALL BE COMPLETED PRIOR TO FINAL ACCEPTANCE.
- ☐ THE REQUESTER OR DEVELOPER SHALL BE RESPONSIBLE FOR REPAIR OR REPLACEMENT OF ALL CURB AND GUTTER OR SIDEWALK DAMAGED AFTER APPROVAL BY THE CITY ENGINEER OF WORK COMPLETED BY THE CONTRACTOR.

1G1.0

BPLW
Architects & Engineers, Inc.
2200 Uptown Blvd. NE
Suite 400
Albuquerque, New Mexico 87110
(505) 881-2758
Designing to Shape the Future



48 West First Street
Suite 100
Mesa, Arizona 85201
(480) 827-2758

BPLW ARCHITECTS & ENGINEERS, INC.

Designing to Shape the future

6200 UPTOWN BLVD. NE
SUITE 400
ALBUQUERQUE, NEW MEXICO 87110
(505) 881-2758

REV.	SHEETS	CITY ENGINEER	DATE	USER DEPARTMENT	DATE	USER DEPARTMENT	DATE
ENGINEERS STAMP & SIGNATURE		APPROVALS		ENGINEER	DATE	*****	
		DRC Chairman		Bradley A. Bigler	6-7-00	APPROVED FOR CONSTRUCTION	
		Transportation		William C. Smith	6-7-00		
		Water/Wastewater		William C. Smith	6-7-00		
		Hydrology		William C. Smith	6-7-00		
		Parks		William C. Smith	6-7-00		
		Constr. Mngmt.				City Engineer	
		Constr. Coord.		Bradley A. Bigler	6-7-00	Date	
		City Project No.		6101.98		Sheet 1 of 11	

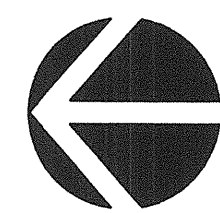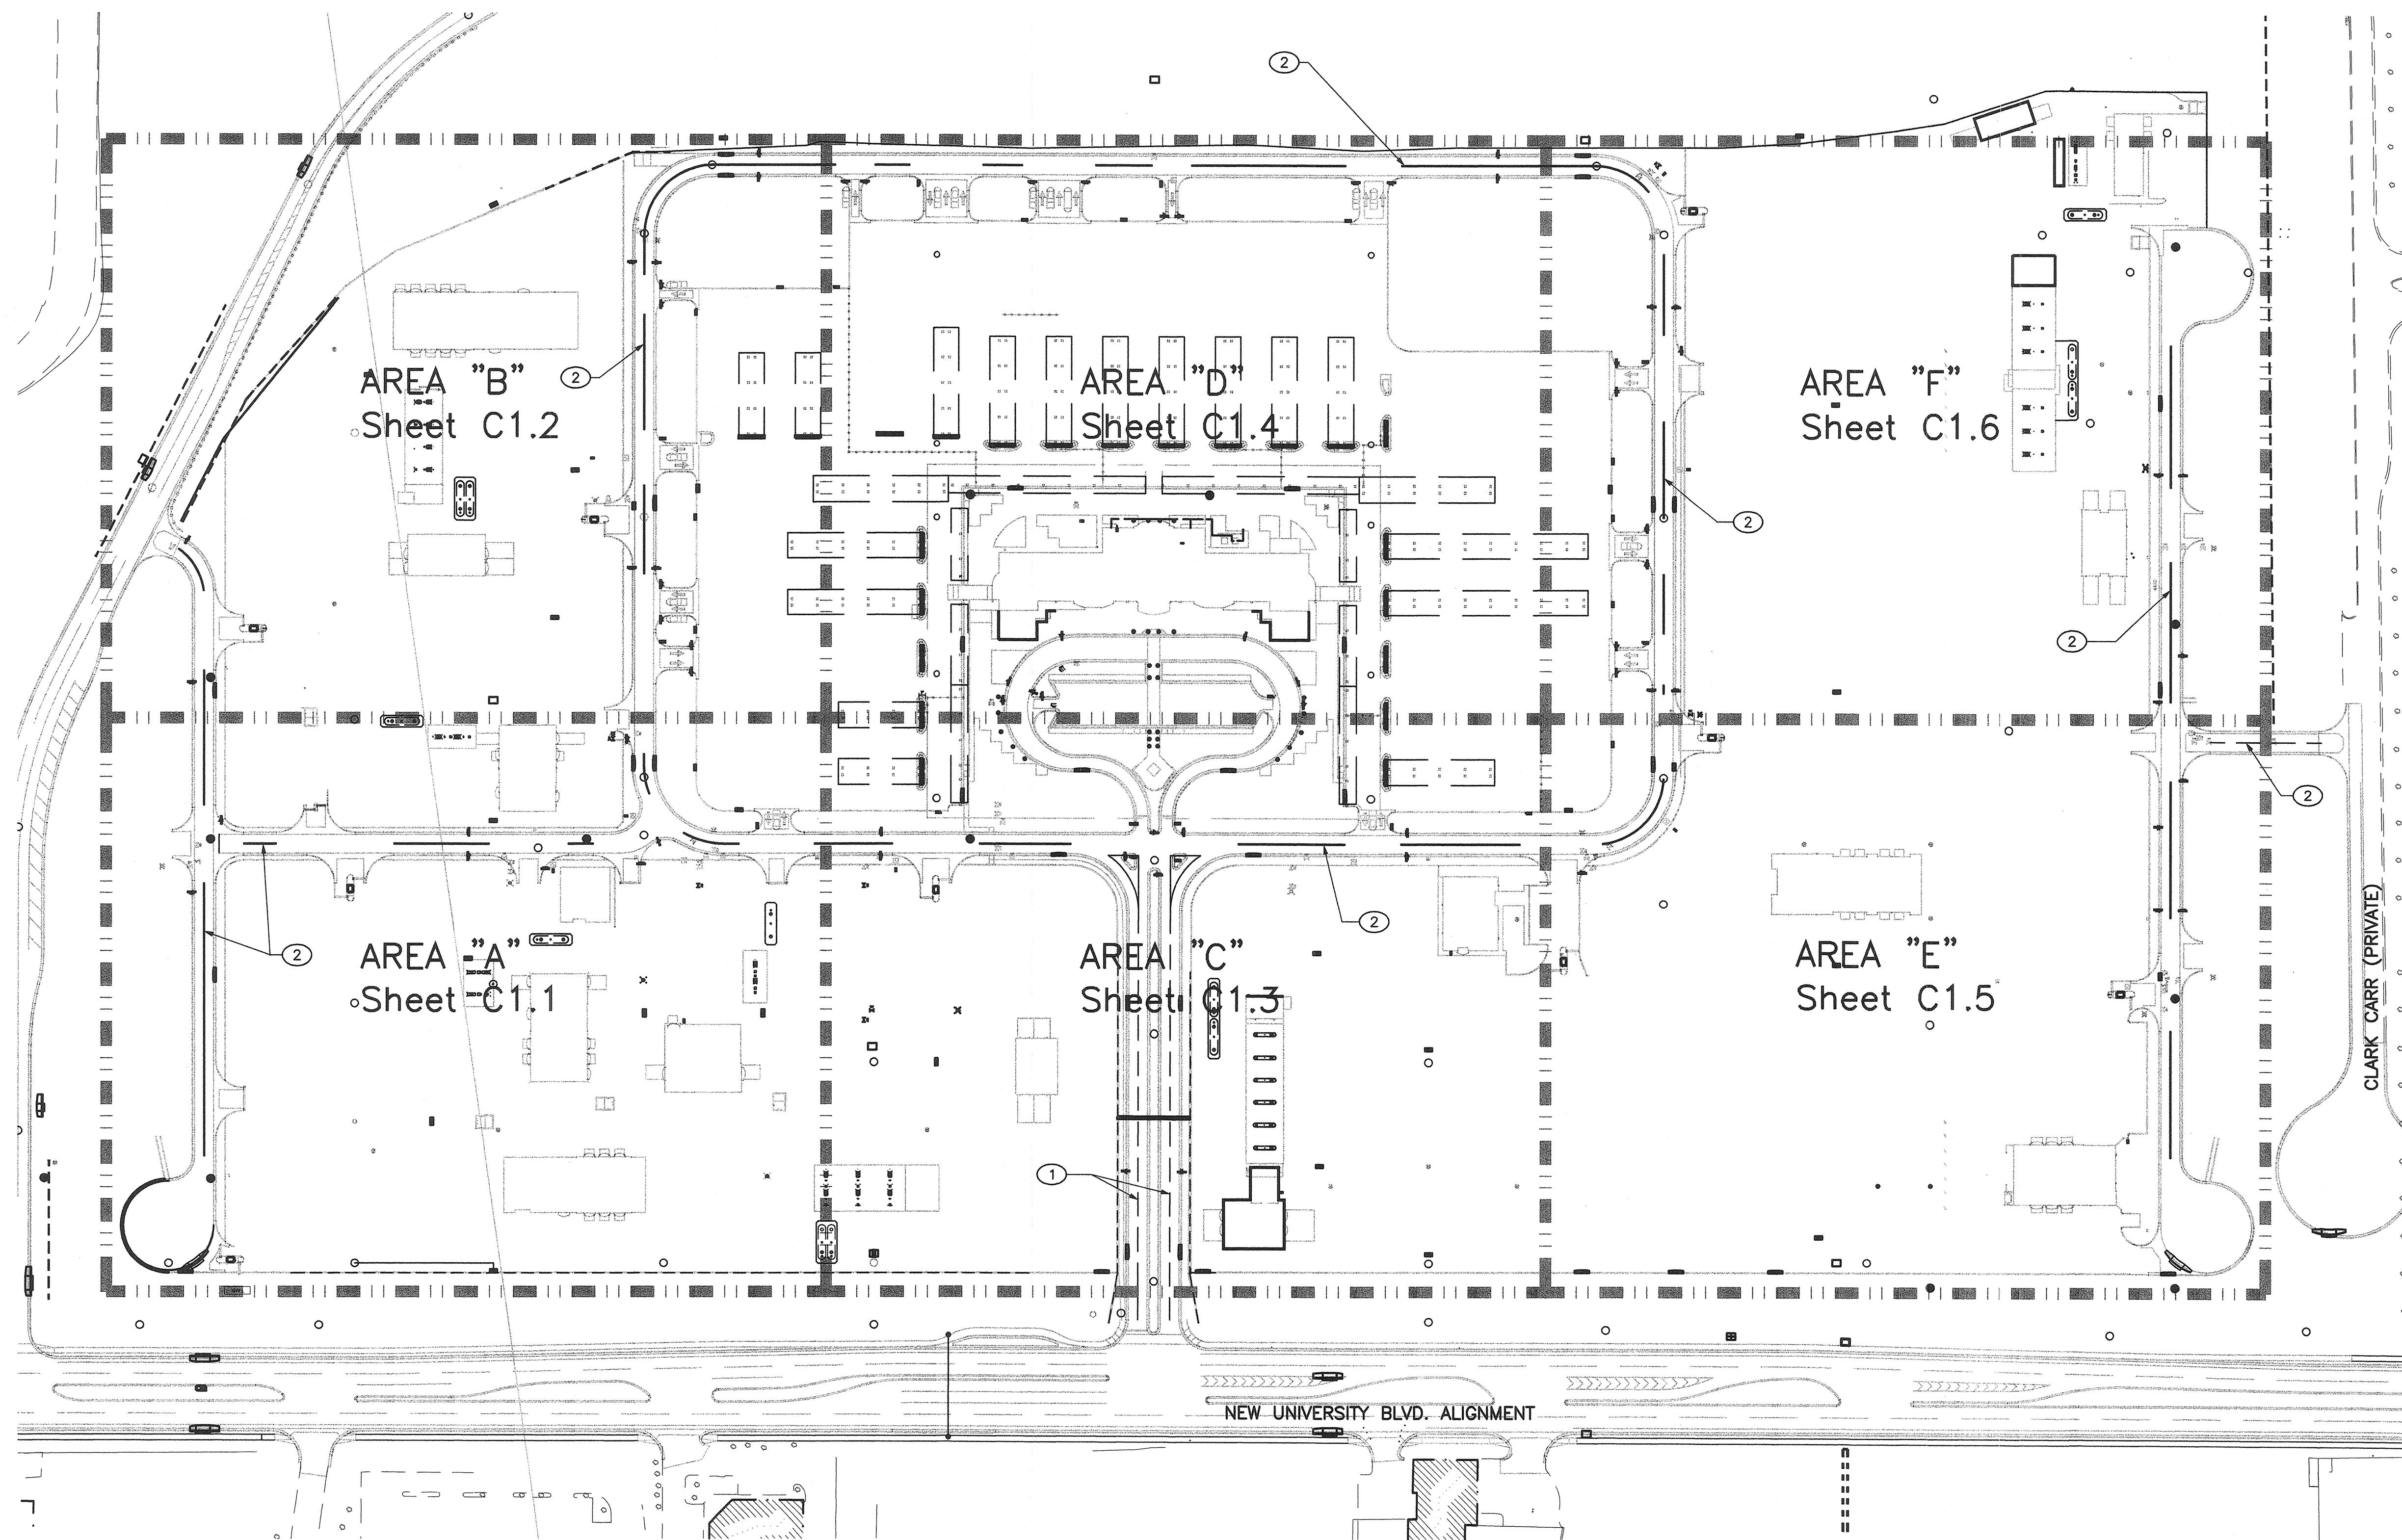

OVERALL TRAFFIC SIGNING/STRIPING PLAN


SCALE: 1"=100'

GENERAL NOTES:


1. See sheet CG.0 for complete legend and general notes that apply to all sheets.

KEYED NOTES:

1. Install 4" wide white reflectorized plastic stripe. (10' stripe/10' skip)
2. Install double 4" yellow reflectorized plastic stripe.

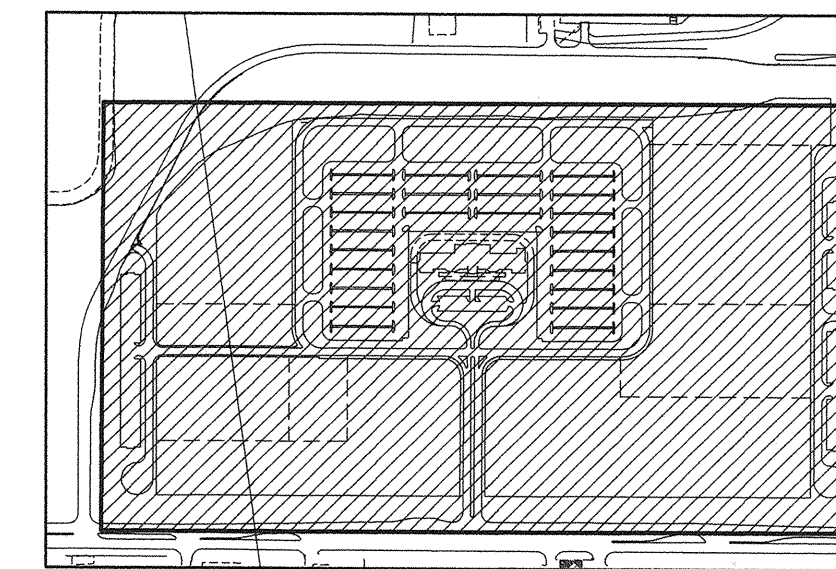

KEY PLAN

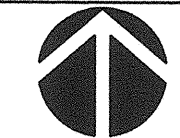



BPLW

Architects & Engineers, Inc.
2200 Updown Blvd. NE
Suite 400
Albuquerque, New Mexico 87110
(505) 881-2799
Designing to Shape the Future



48 West First Street
Suite 100
Mesa, Arizona 85201
(480) 827-2799

CITY OF ALBUQUERQUE
PUBLIC WORKS DEPARTMENT
ENGINEERING DEVELOPMENT GROUP
TITLE: CONSOLIDATED RENTAL CAR FACILITY
SERVICE CENTER AREA
OVERALL TRAFFIC SIGNING/STRIPING PLAN

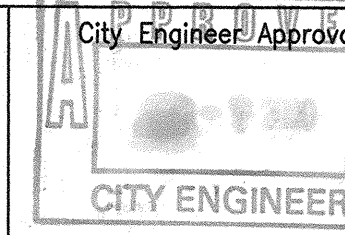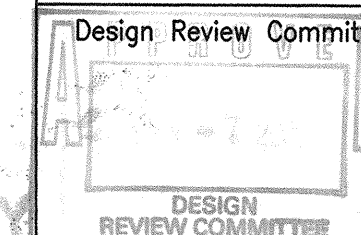


Mo./Day/Yr.	Mo./Day/Yr.

City Project No.
6101.98

Zone Map No.
N-15-Z

Sheet
C1.0

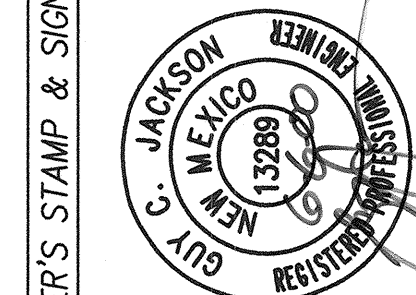


REVISIONS	By	Date
DESIGN		6-2-00
		6-2-00
		6-2-00

SURVEY INFORMATION	Field Notes	Date
No. 2050	URS GREINER	
	WOODWARD CLYDE	


BENCH MARKS	AS BUILT INFORMATION
1"-N16 RESET, AN AOS ALUMINUM CAP APPROX. S. 10'E. 1180 FT. FROM THE INTERSECTION OF EXISTING ACCESS ROAD "B" AND CLARK CARR BLVD; AND APPROX. 100 FT SSE OF A CHAIN LINK GATE ALIGNED EAST TO WEST. ELEV.=5308.73	Contractor Work Started By Accepted By Field Drawings Checked By Recorded By No.

08/99

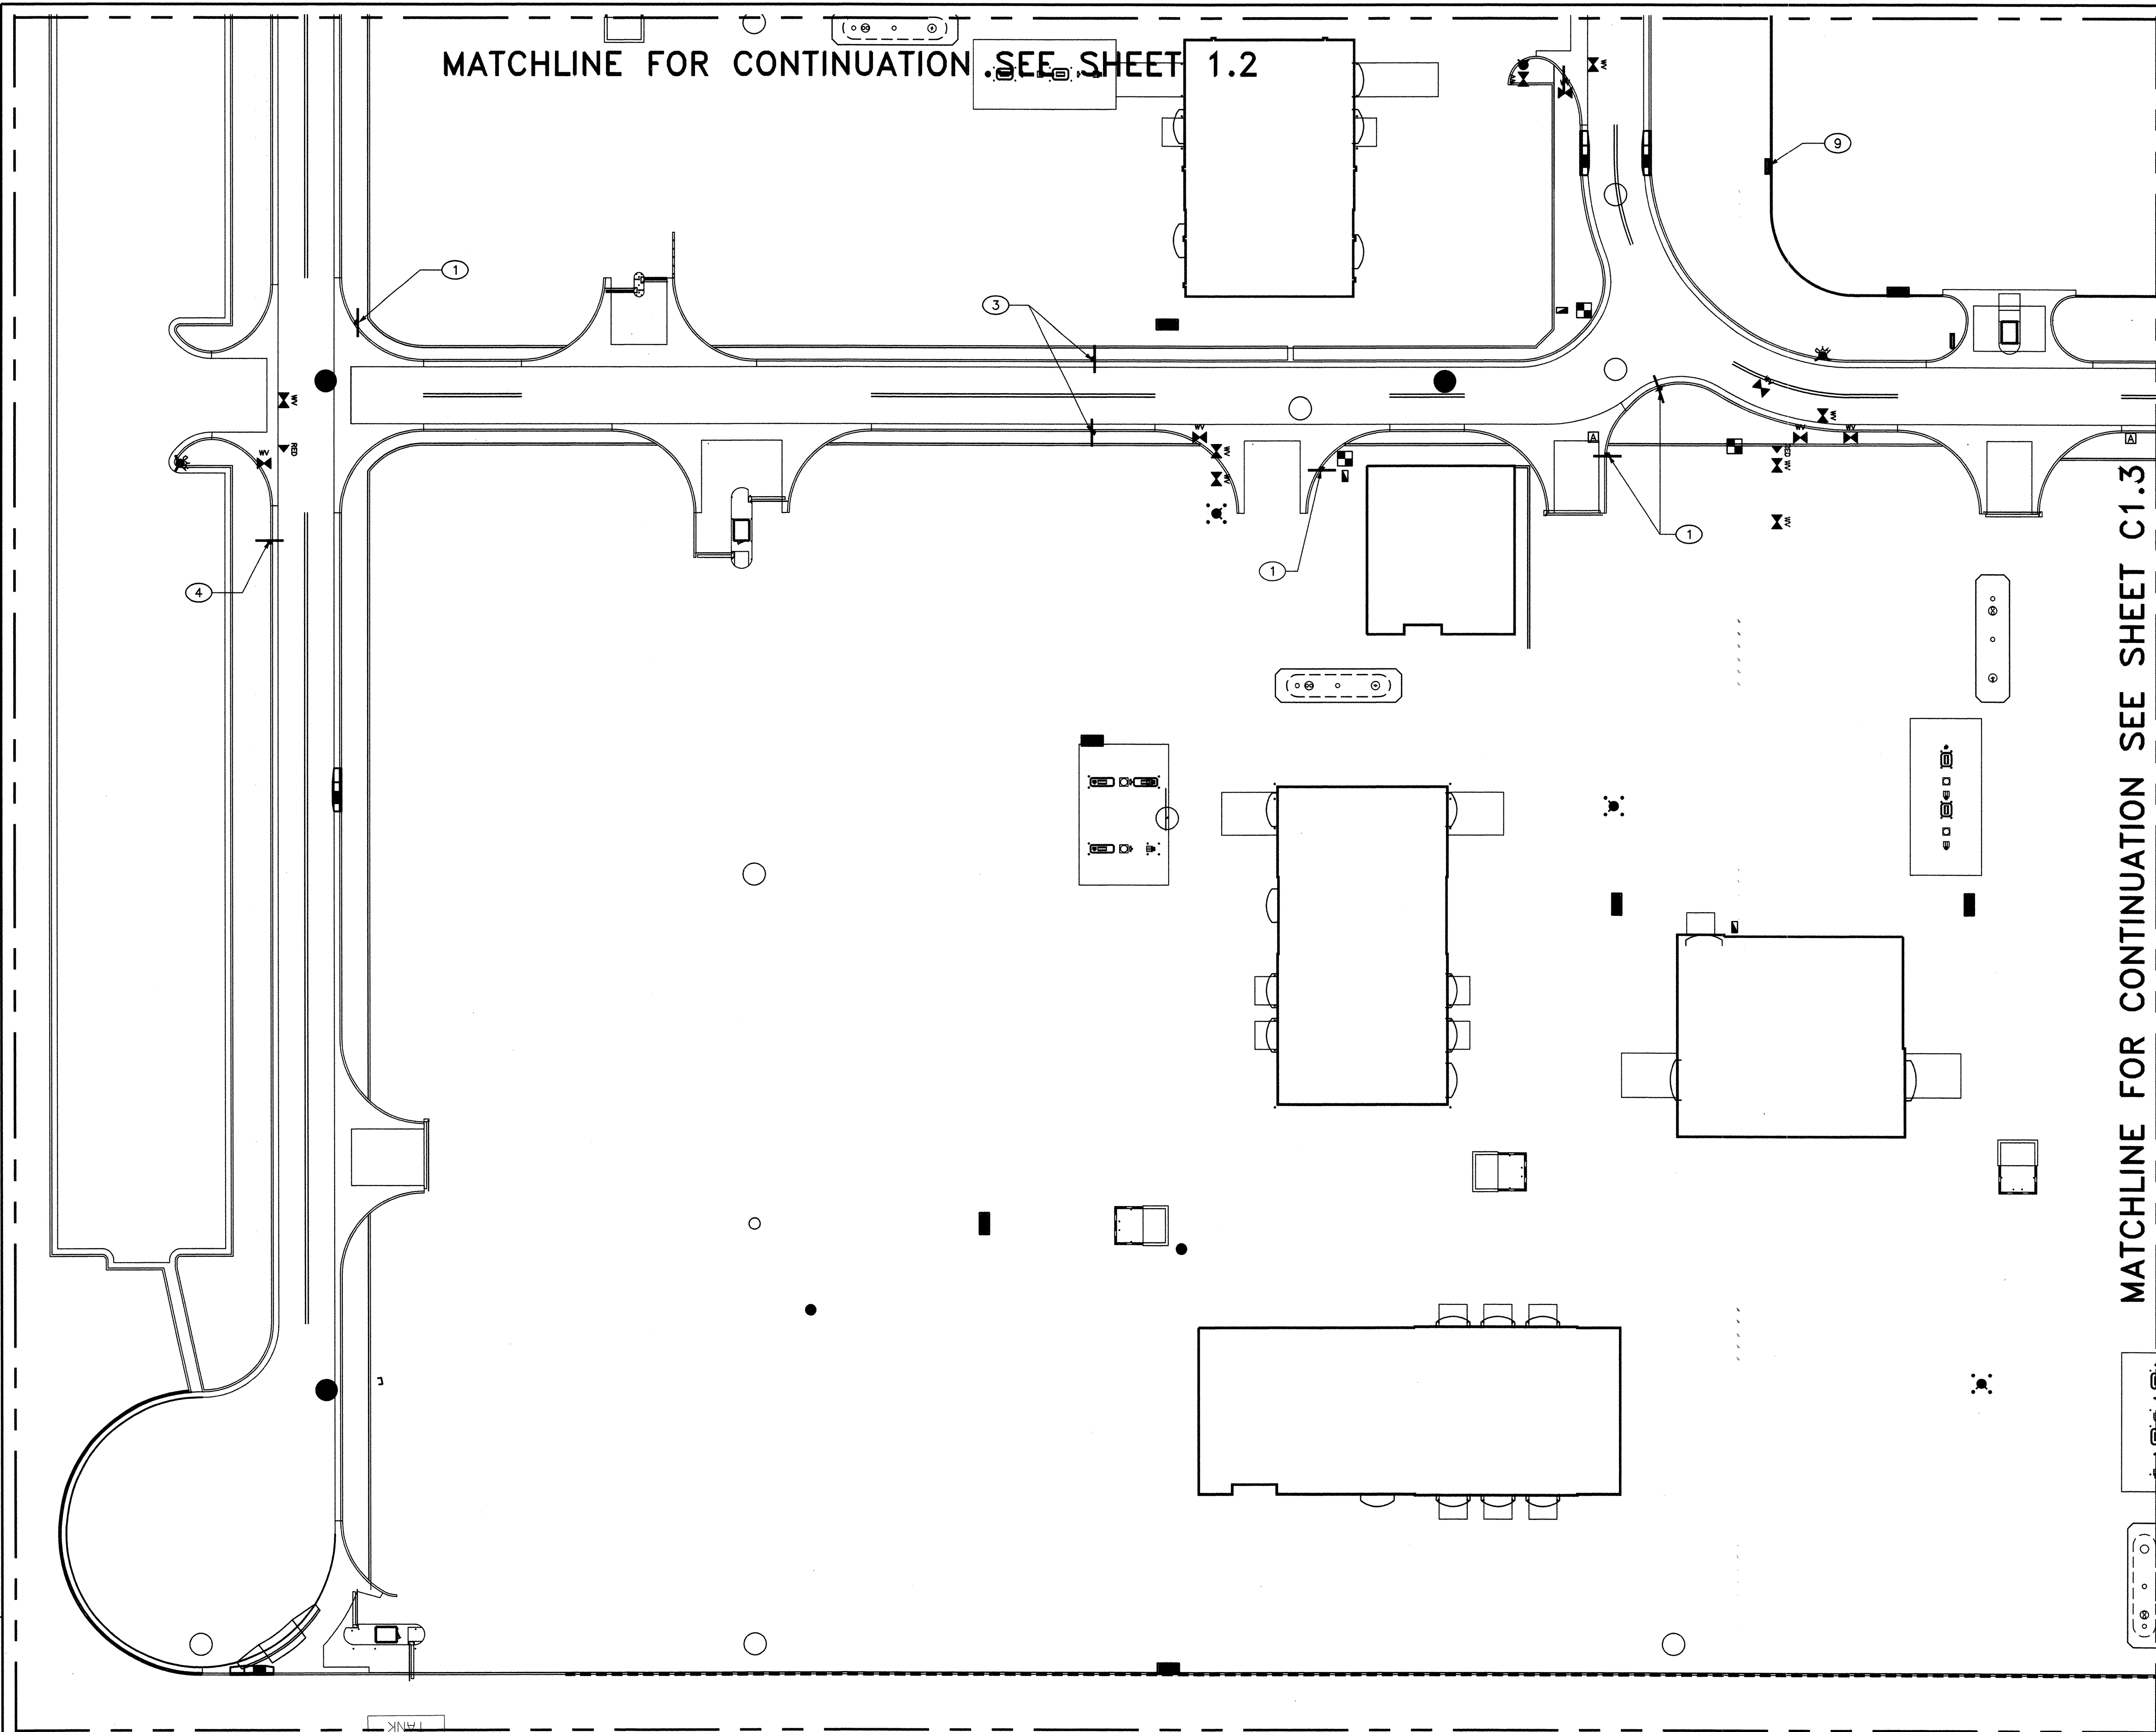

MATCHLINE FOR CONTINUATION .SEE SHEET 1.2

MATCHLINE FOR CONTINUATION SEE SHEET C1.3

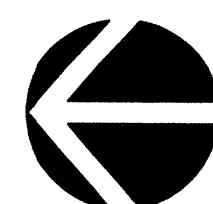

OVERALL TRAFFIC SIGNING/STRIPING PLAN

SCALE: 1"=30'


FOR INFORMATION ONLY

GENERAL NOTES:

1. See sheet CG.0 for complete legend and general notes that apply to all sheets.
2. Traffic Control Signage Mounting shall be per detail 1/C5.1 unless otherwise specified.

KEYED NOTES:

1. Install STOP sign. See detail 2/C5.1.
2. Not used.
3. Install SPEED LIMIT sign. See detail 4/C5.1.
4. Install DEAD END sign. See detail 5/C5.1.
5. Not used.
6. Not used.
7. Not used.
8. Not used.
9. Install site specific architectural sign. See architectural plans.
10. Not used.
11. Not used.

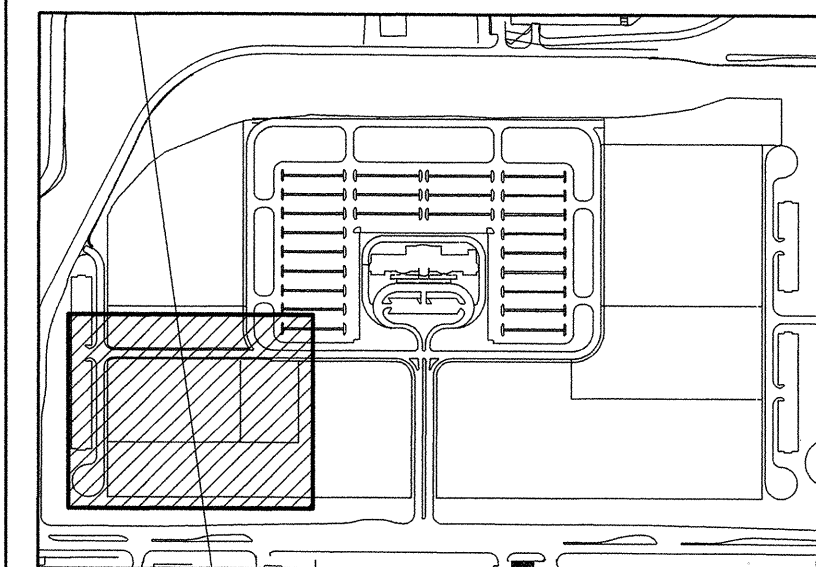

KEY PLAN

BPLW



Architects & Engineers, Inc.
8200 Uptown Blvd. NE
Suite 400
Albuquerque, New Mexico 87110
(505) 861-2759

49 West First Street
Suite 100
Mesa, Arizona 85201
(480) 827-2759

Designing to Shape the Future

CITY OF ALBUQUERQUE
PUBLIC WORKS DEPARTMENT
ENGINEERING DEVELOPMENT GROUP

TITLE: CONSOLIDATED RENTAL CAR FACILITY
SERVICE CENTER AREA
STRIPING AND SIGNAGE AREA "A"

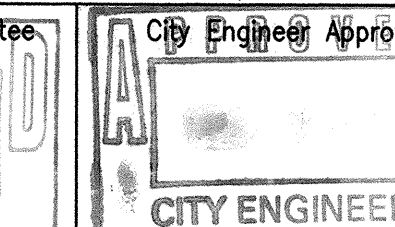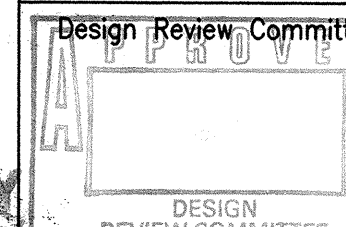

Last Design Update


No./Day/Yr.

No./Day/Yr.

City Project No.
6101.98

Zone Map No.
N-15-Z



Sheet
C1.1

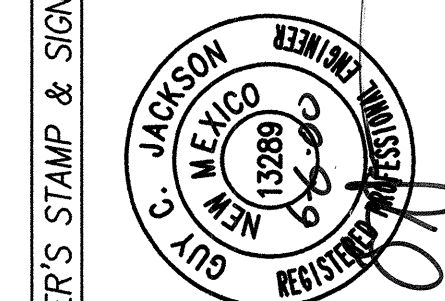

REVISIONS	
No.	Date
1	6-2-00
2	6-2-00
3	6-2-00

SURVEY INFORMATION	
No.	Date
2050	URS GREINER
WOODWARD CLYDE	
AS BUILT INFORMATION	
Contractor	Work
By	By
Accepted By	Accepted By
Drawn By	Drawn By
Checked By	Checked By
Recorded By	Recorded By
No.	No.
1	1
2	2
3	3
4	4
5	5
6	6
7	7
8	8
9	9
10	10
11	11

08/99

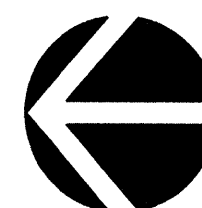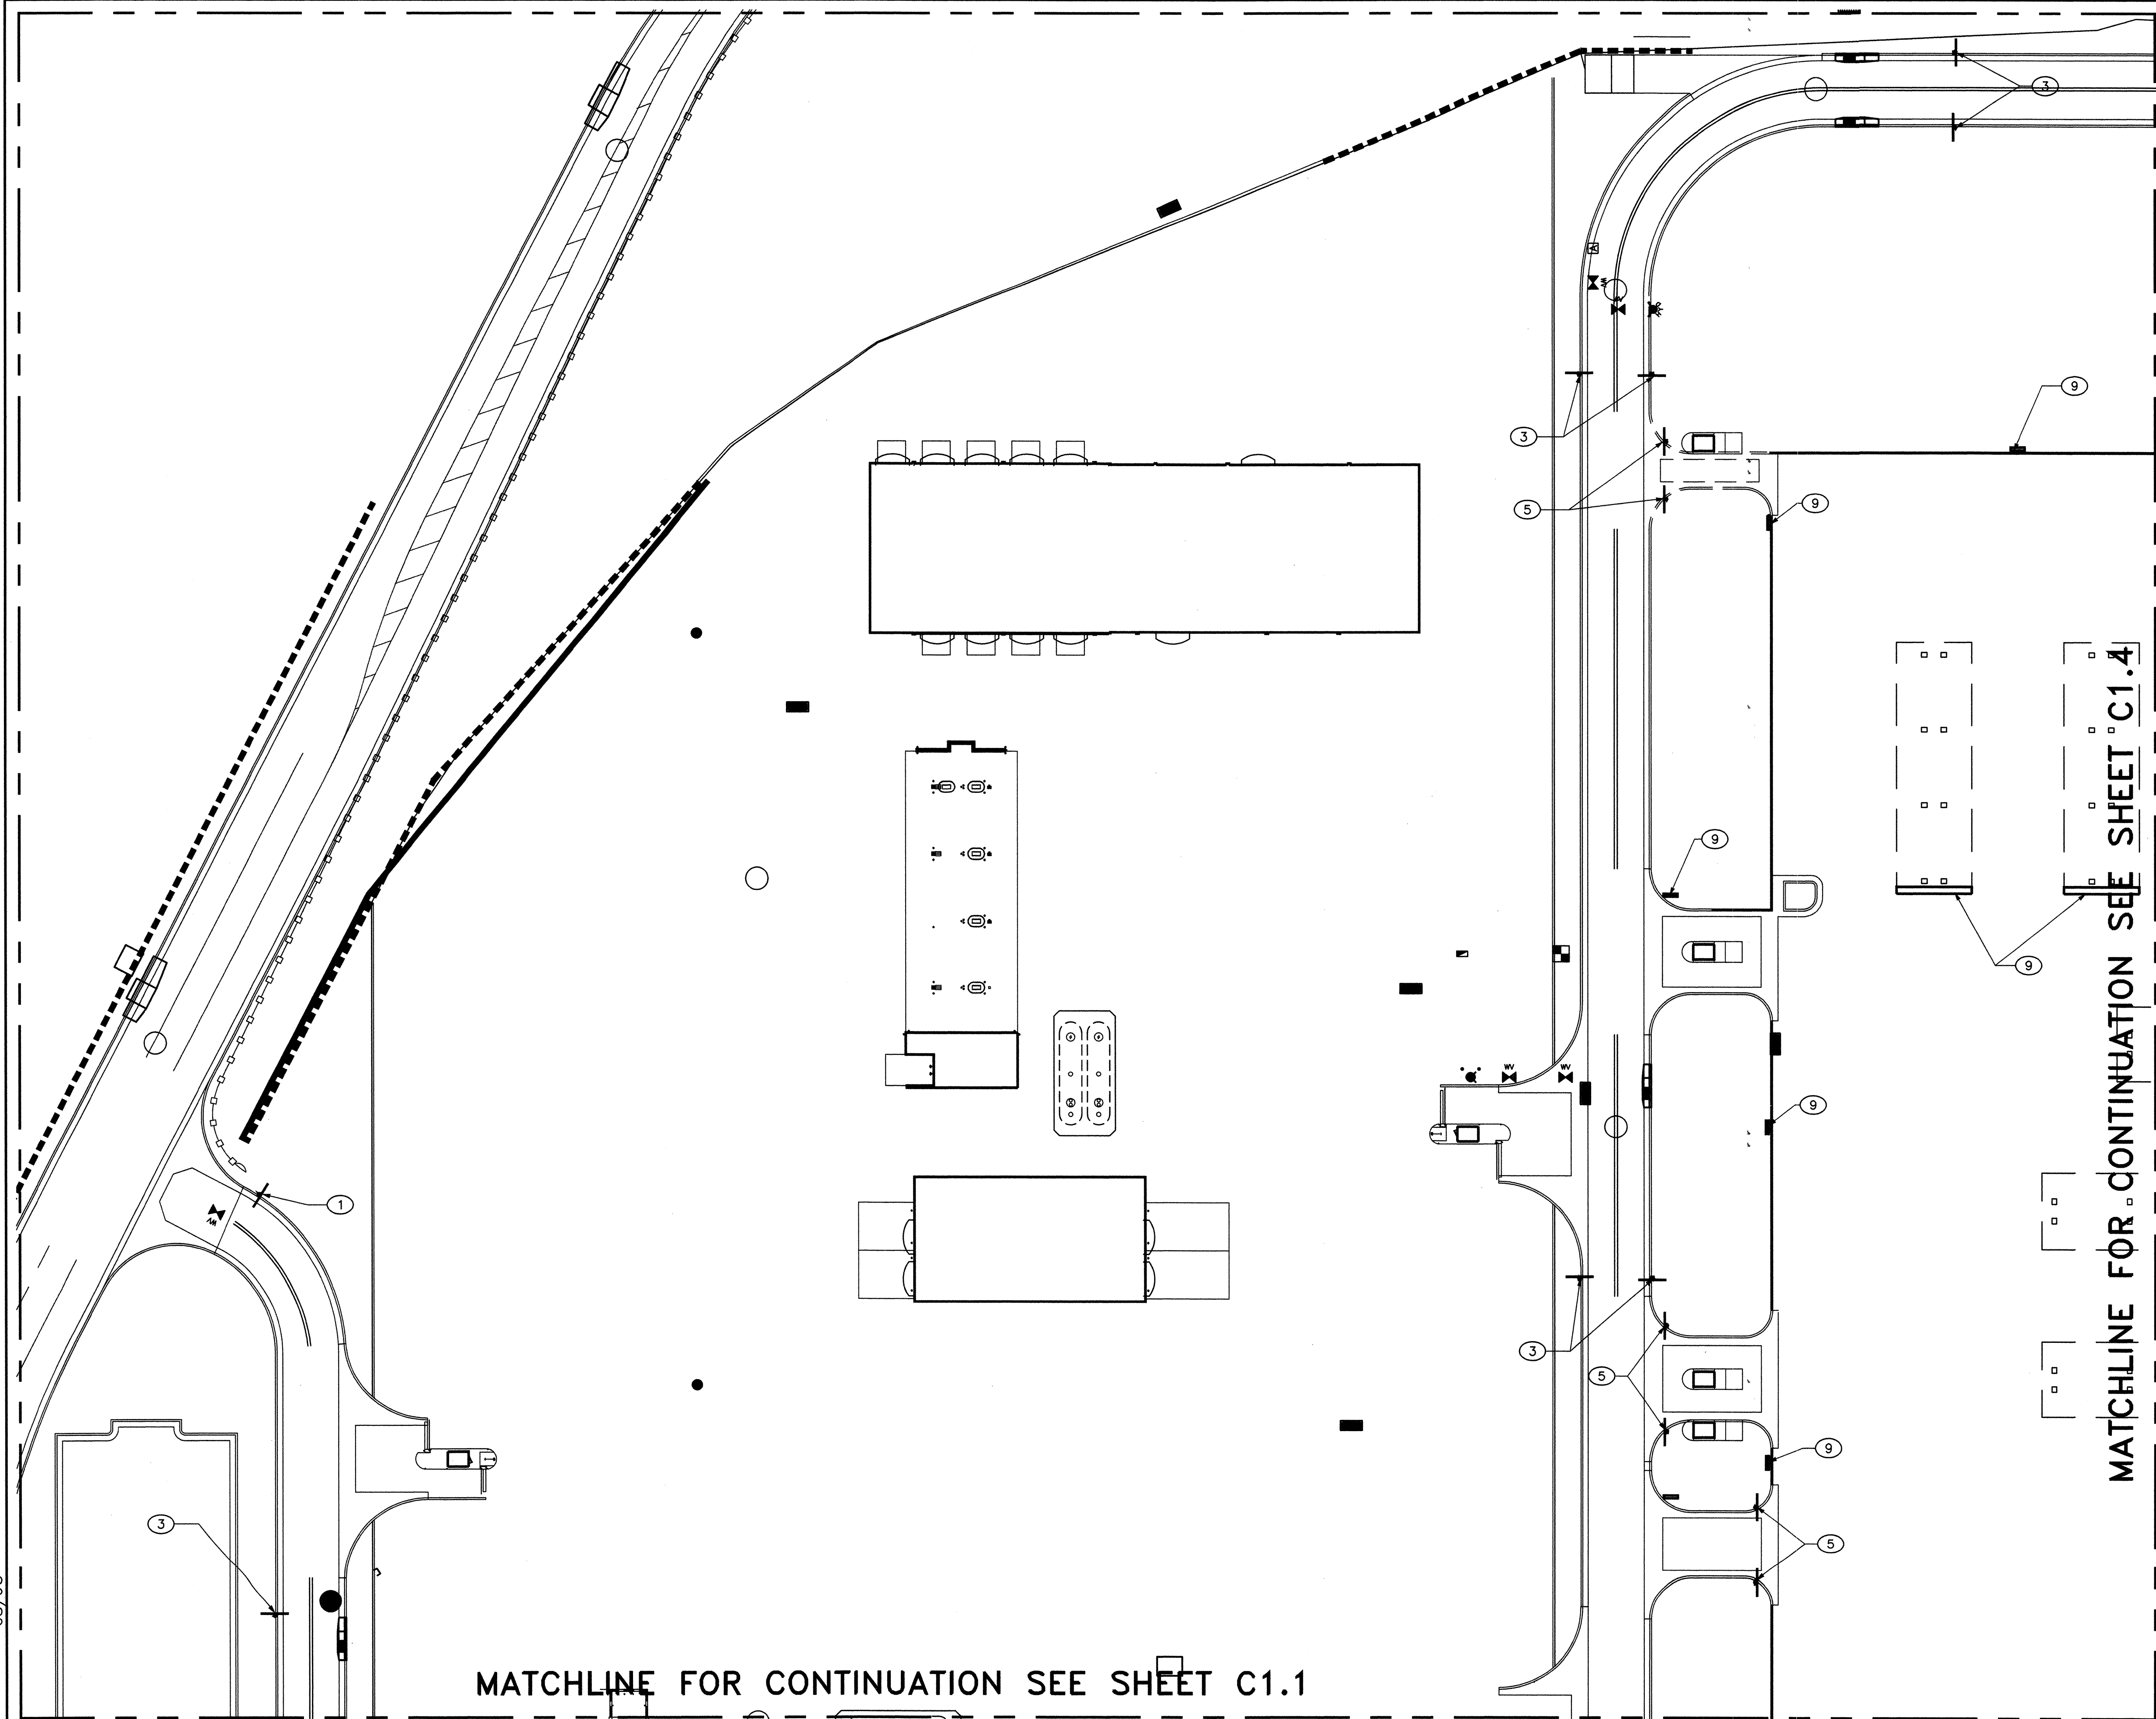

OVERALL TRAFFIC SIGNING/STRIPING PLAN


SCALE: 1"=30'

GENERAL NOTES:

1. See sheet CG.0 for complete legend and general notes that apply to all sheets.
2. Traffic Control Signage Mounting shall be per detail 1/C5.1 unless otherwise specified.

KEYED NOTES:

1. Install STOP sign. See detail 2/C5.1.
2. Not used.
3. Install SPEED LIMIT sign. See detail 4/C5.1.
4. Not used.
5. Install DO NOT ENTER sign. See detail 6/C5.1.
6. Not used.
7. Not used.
8. Not used.
9. Install site specific architectural sign. See architectural plans.
10. Not used.
11. Not used.

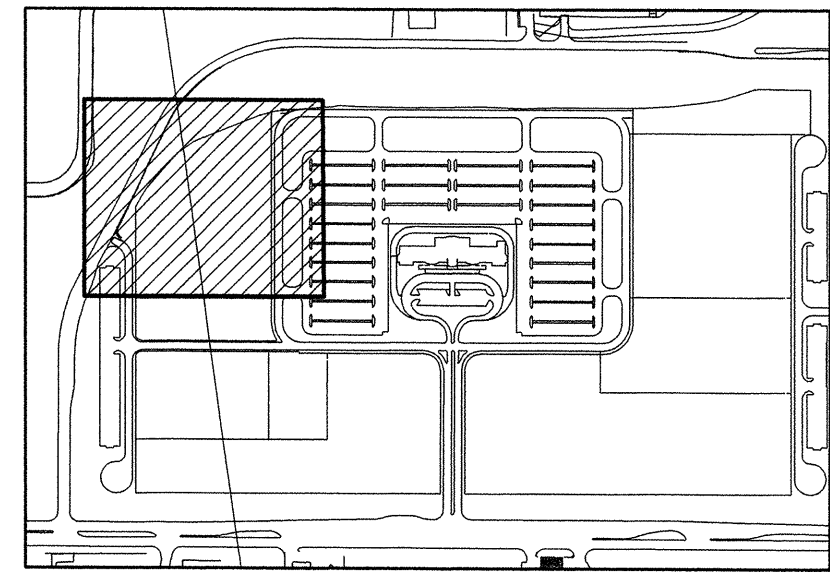

KEY PLAN

BPLW

Architects & Engineers, Inc.
8200 Uptown Blvd. NE
Suite 400
Albuquerque, New Mexico 87110
(505) 881-2759




49 West First Street
Suite 100
Albuquerque, New Mexico 85201
(480) 827-2759

Designing to Shape the Future



CITY OF ALBUQUERQUE
PUBLIC WORKS DEPARTMENT
ENGINEERING DEVELOPMENT GROUP


TITLE: CONSOLIDATED RENTAL CAR FACILITY
SERVICE CENTER AREA
STRIPING AND SIGNAGE AREA "B"

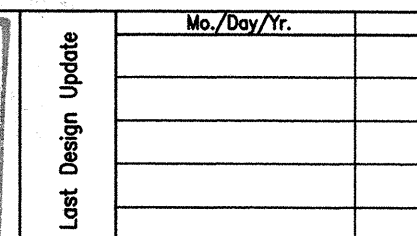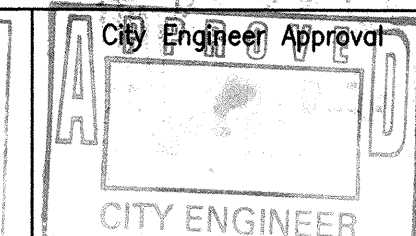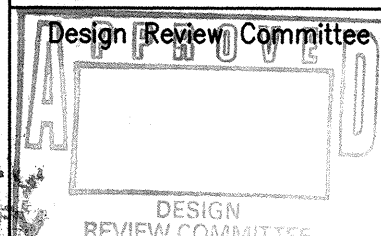

City Project No.
6101.98

Zone Map No.
N-15-Z

Sheet
C1.2

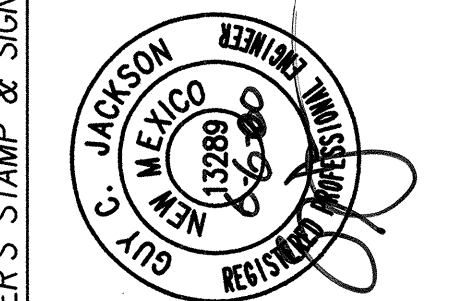

REVISIONS	Remarks	Date
DESIGN		6-2-00
		6-2-00
		6-2-00

Designed By: MFD/NL
Drawn By: DLW
Checked By: GCJ

Mo./Day/Yr.


Mo./Day/Yr.

Mo./Day/Yr.

Mo./Day/Yr.

MATCHLINE FOR CONTINUATION SEE SHEET C1.2

MATCHLINE FOR CONTINUATION SEE SHEET C1.6

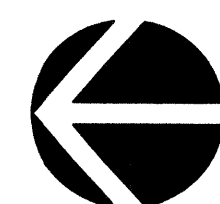

FOR INFORMATION ONLY


City Project No.	Zone Map No.	Sheet	Of
6101.98	N-15-Z	C1.4	

[illegible]

MATCHLINE FOR CONINUATION SEE SHEET C1.3



OVERALL TRAFFIC SIGNING/STRIPING PLAN

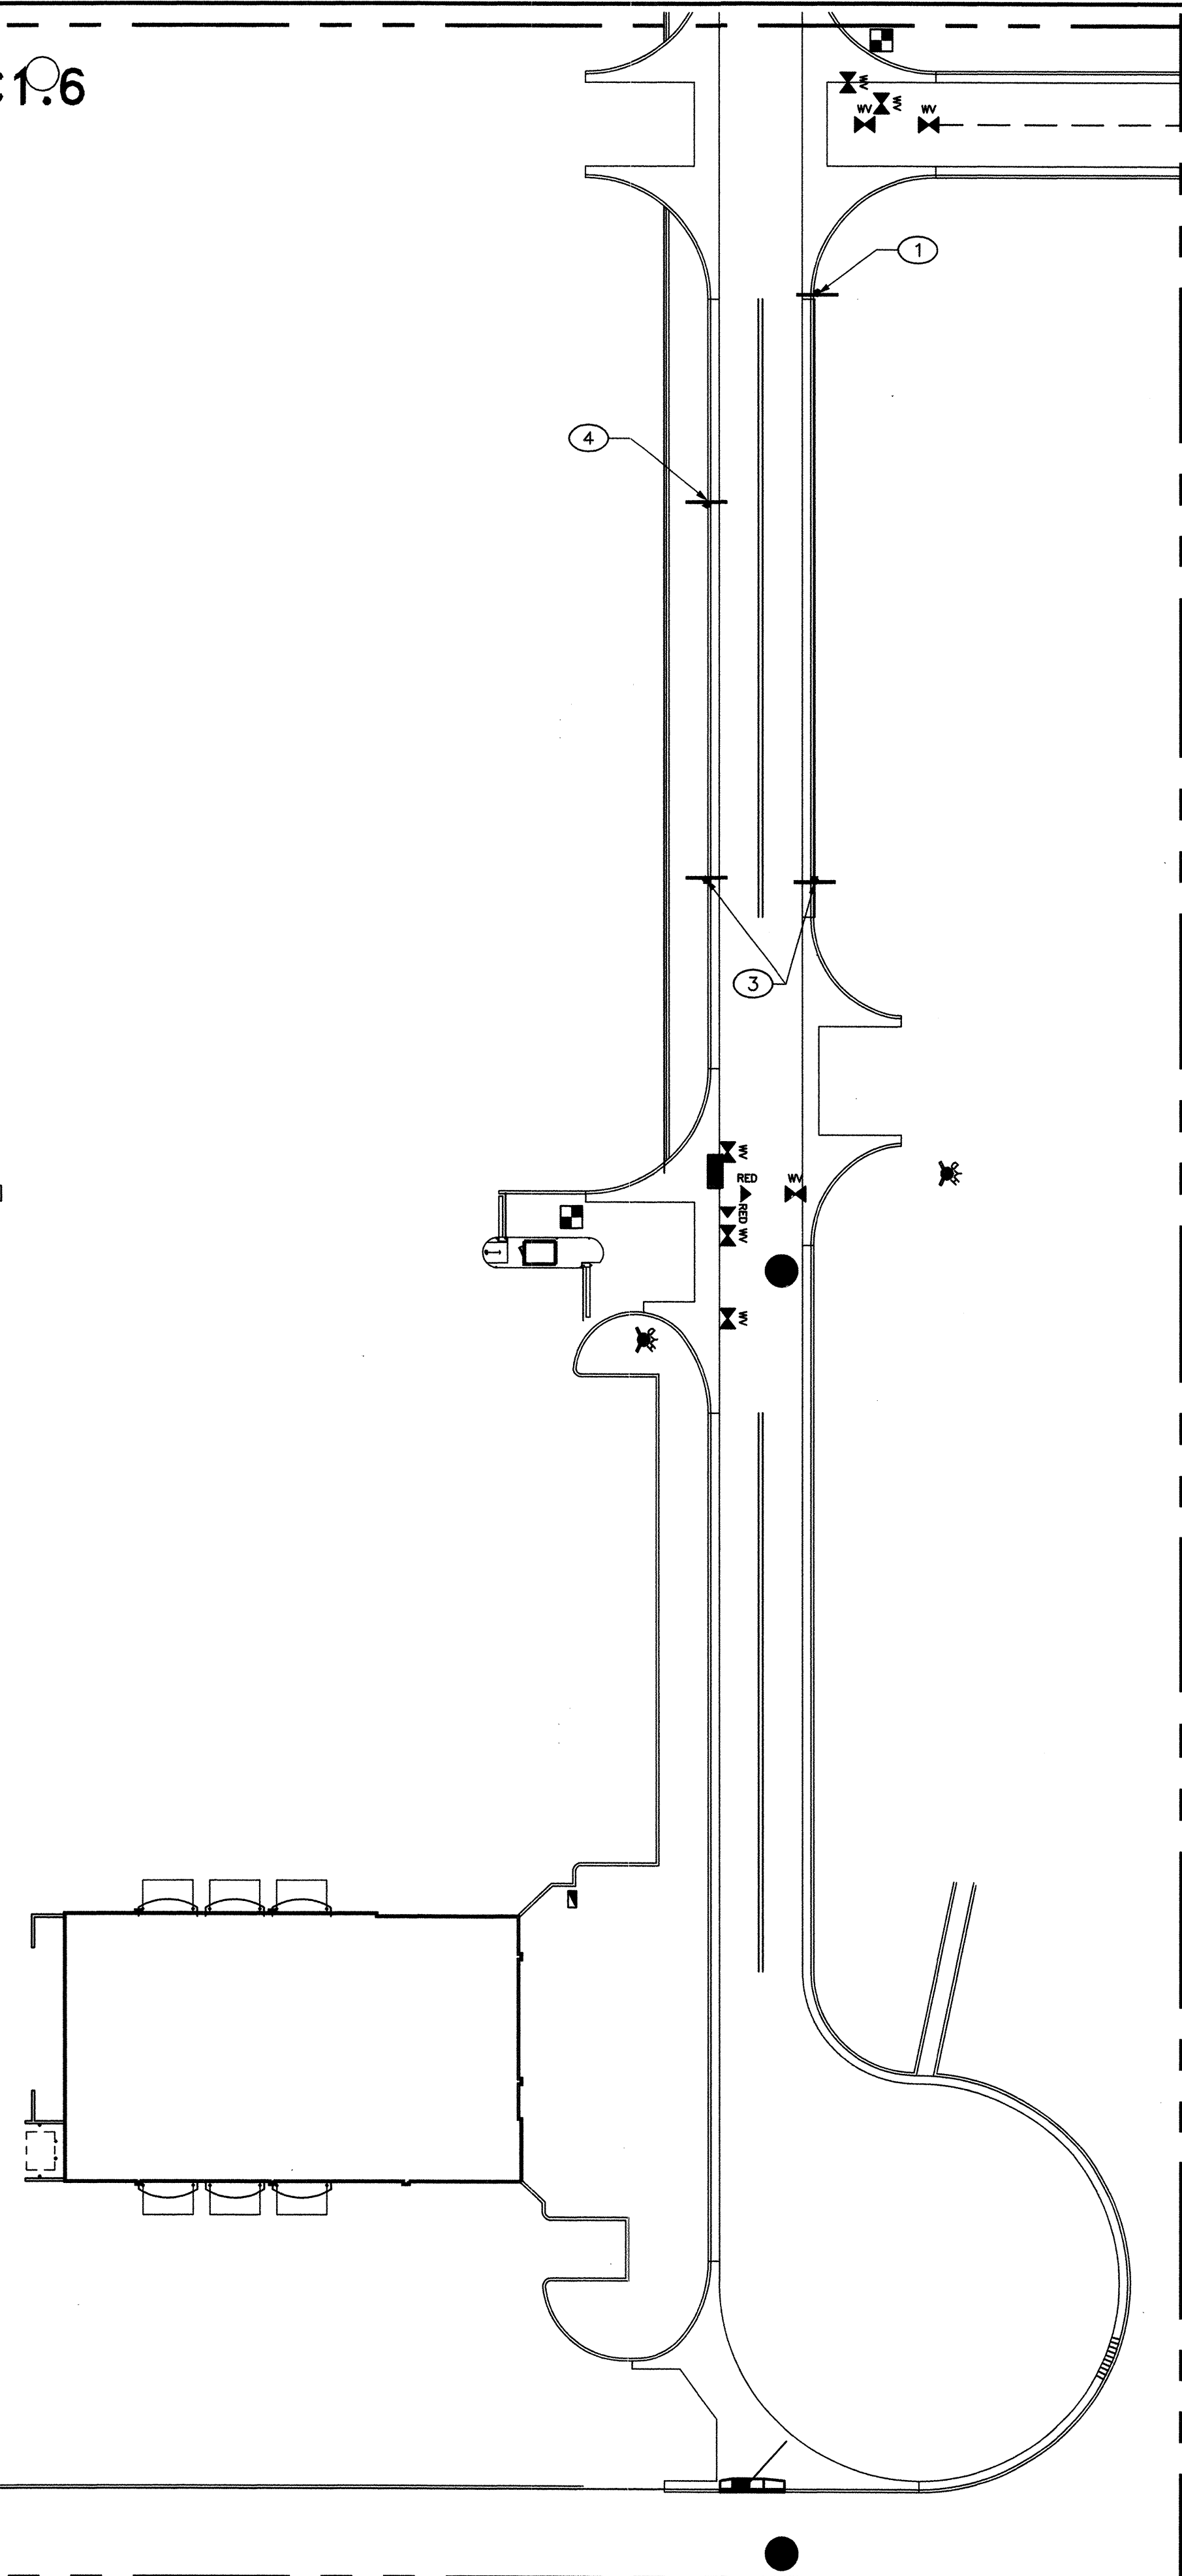

KEY PLAN

Architects & Engineers, Inc.
6200 Uptown Blvd. NE
Suite 400
Albuquerque, New Mexico 87110
(505) 881-2759

Designing to Shape

49 West First Street
Suite 100
Mesa, Arizona 85201
(480) 827-2759

CITY OF ALBUQUERQUE
PUBLIC WORKS DEPARTMENT
ENGINEERING DEVELOPMENT GROUP

TITLE:	CONSOLIDATED RENTAL CAR FACILITY SERVICE CENTER AREA STRIPING AND SIGNAGE AREA "E"
--------	---

Design Review Committee

DESIGN
REVIEW COMMITTEE

City Engineer Approval

CITY ENGINEER

Last Design Update

City Project No. 6101.98

Zone Map No.
N-15-Z


Sheet **C1.5** Of

[illegible]

08/99

MATCHLINE FOR CONTINUATION SEE SHEET C1.4

MATCHLINE FOR CONTINUATION SEE SHEET C1.5

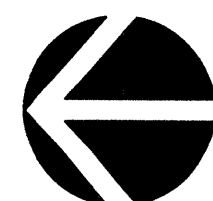

OVERALL TRAFFIC SIGNING/STRIPING PLAN


SCALE: 1"=30'

GENERAL NOTES:

1. See sheet CG.0 for complete legend and general notes that apply to all sheets.
2. Traffic Control Signage Mounting shall be per detail 1/C5.1 unless otherwise specified.

KEYED NOTES:

1. Install STOP sign. See detail 2/C5.1.
2. Not used.
3. Install SPEED LIMIT sign. See detail 4/C5.1.
4. Install DEAD END sign. See detail 5/C5.1.
5. Install DO NOT ENTER sign. See detail 6/C5.1.
6. Not used.
7. Not used.
8. Not used.
9. Install site specific architectural sign. See architectural plans.
10. Not used.
11. Not used.

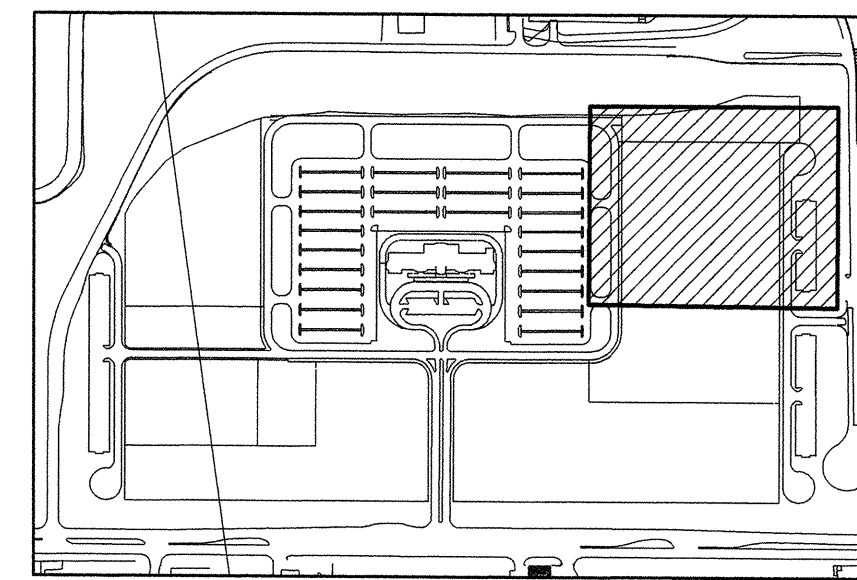

KEY PLAN

BPLW



Architects & Engineers, Inc.
8200 Uptown Blvd. NE
Suite 400
Albuquerque, New Mexico 87110
(505) 881-2759

49 West First Street
Suite 100
Mesa, Arizona 85201
(480) 827-2759

Designing to Shape the Future

CITY OF ALBUQUERQUE
PUBLIC WORKS DEPARTMENT
ENGINEERING DEVELOPMENT GROUP

TITLE: CONSOLIDATED RENTAL CAR FACILITY
SERVICE CENTER AREA
STRIPING AND SIGNAGE AREA "F"

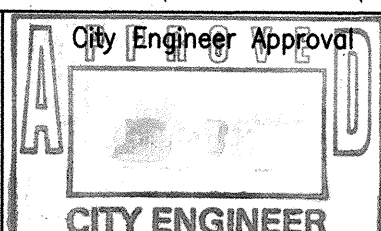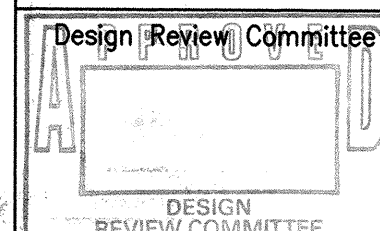


Last Design Update

No./Day/Yr.	No./Day/Yr.

City Project No.
6101.98

Zone Map No.
N-15-Z


Sheet
C1.6

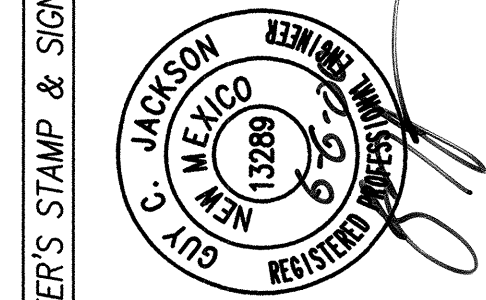

REVISIONS	By	Date
DESIGN		6-2-00
		6-2-00
		6-2-00

SURVEY INFORMATION		BENCH MARKS		AS BUILT INFORMATION	
No.	Field Notes	No.	Date	Contractor	Date
2050	URS GREINER				
	WOODWARD CLYDE				

MICRO-FILM INFORMATION	
Recorded By	No.

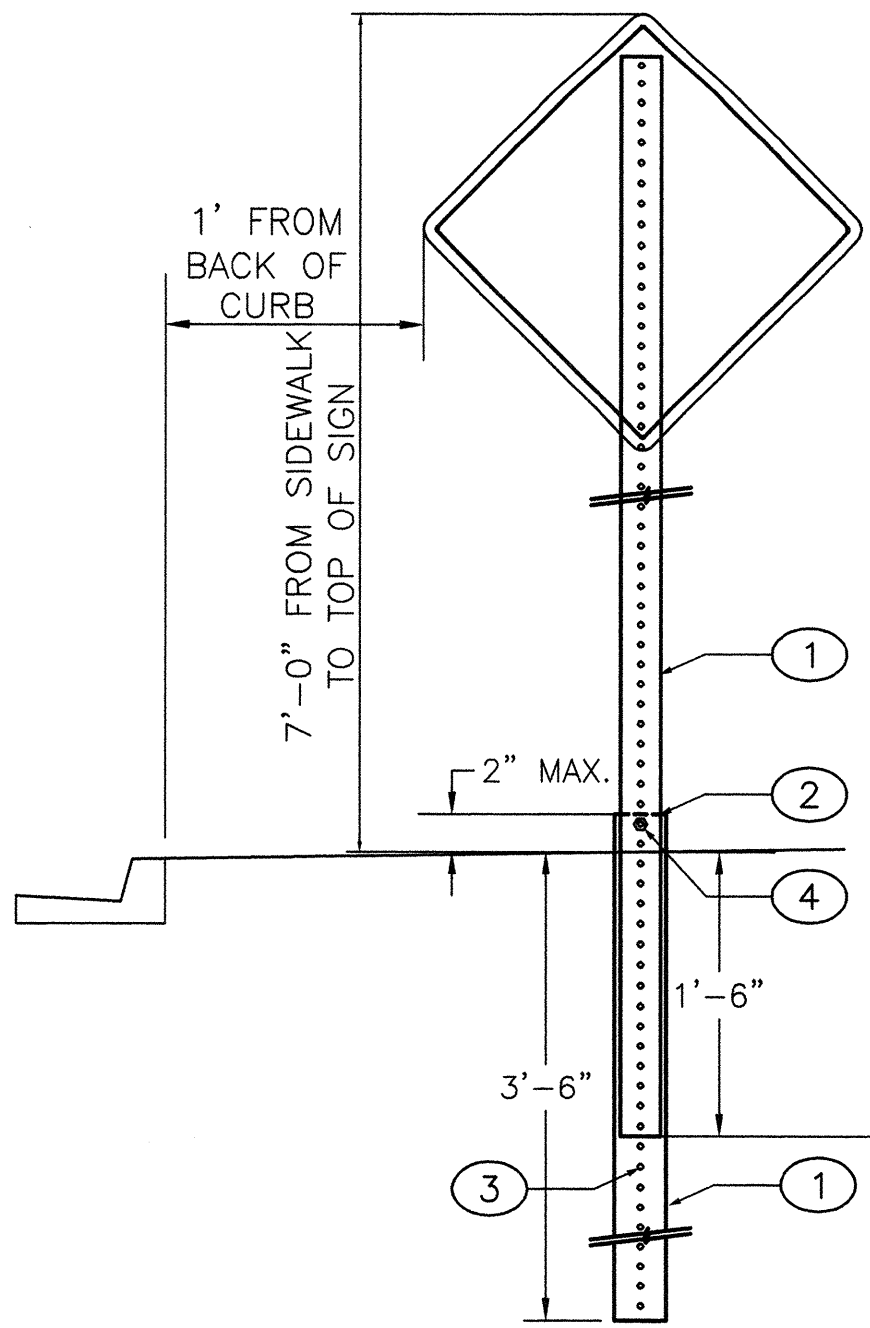


1. TRAFFIC SIGN MOUNTING DETAIL
C1.1 NOT TO SCALE CS.2

POST KEYED NOTES:

- 3"x3" x4'-0" BASE POST OF 3/16" WALL THICKNESS TO BE USED WITH 2 1/2"x2 1/2" 0.1345 POST.
- BREAKING POINT.
- 7/16" HOLES 1" O.C. (BOTH POSTS).
- 3/8" HEX HEAD BOLT WITH WASHER & HEX. LOCK NUT OR 3/8" DRIVE RIVETS.

GROUND INSTALLATION:


- DRIVE BASE POST UNTIL ONE HOLE IS EXPOSED ABOVE GROUND FOR RIVET OR BOLT INSTALLATION.
- INSERT SIGN POST 1'-6" AND FASTEN WITH 2 EACH 3/8" DRIVE RIVET OR A 3/8" BOLT.
- THE HOLE PATTERN SHOWN IS ONLY REQUIRED IN THE AREA OF THE BREAKAWAY INFLUENCE AND AT THE SIGN PANEL LOCATION (HOLES MAY BE FIELD DRILLED).

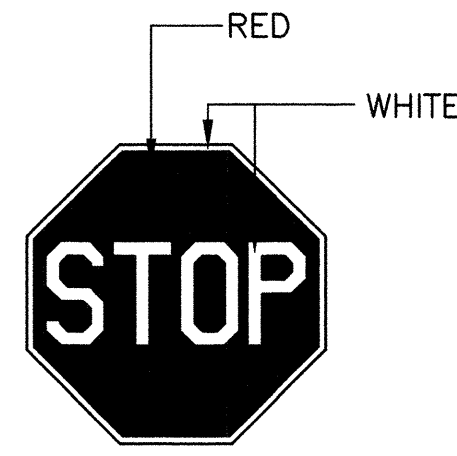


R1-1
30"x30"

- NOTE: INSTALL 24" SOLID WHITE REFLECTORIZED PLASTIC STRIPE ADJACENT TO ALL STOP SIGNS. TO COVER WHOLE WIDTH OF LANE.

2. STOP SIGN
C1.1 NOT TO SCALE CS.1

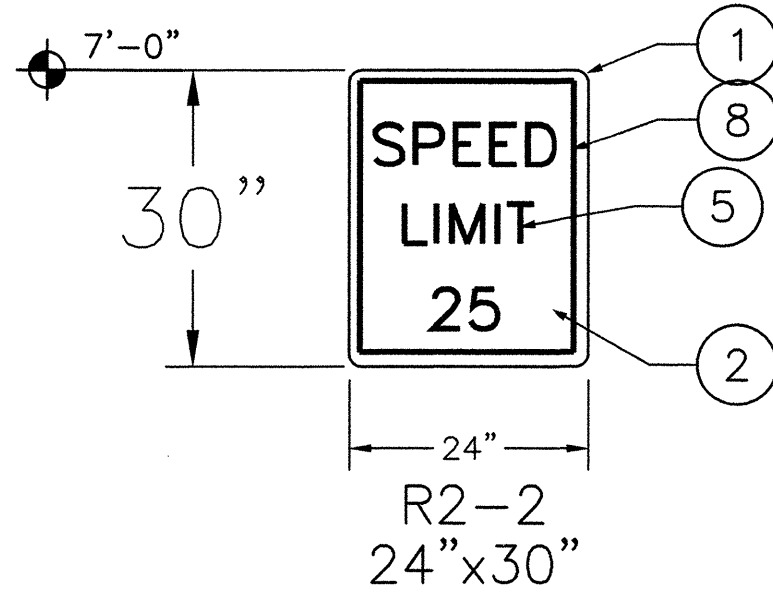


4. SPEED LIMIT SIGN
C1.1 NOT TO SCALE CS.1

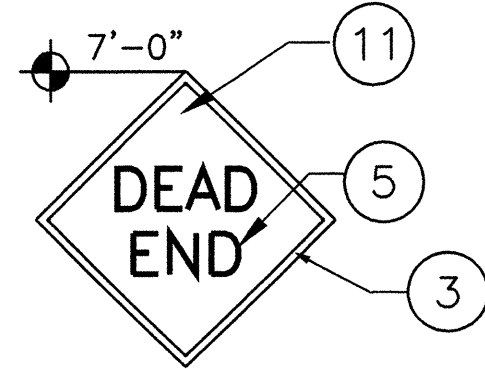


W14-1
30"x30"

5. DEAD END SIGN
C1.1 NOT TO SCALE CS.1

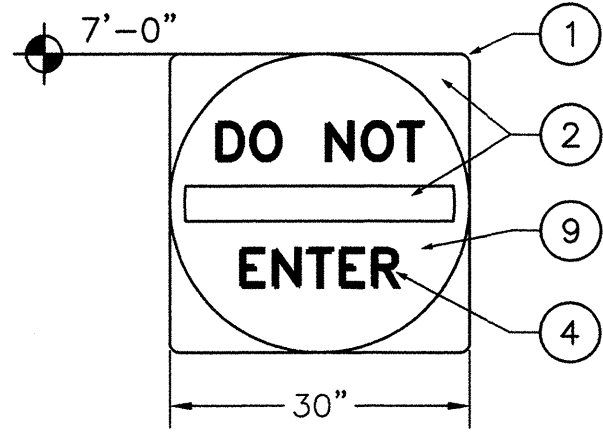


R5-1
30"x30"

6. DO NOT ENTER SIGN
C1.2 NOT TO SCALE CS.1

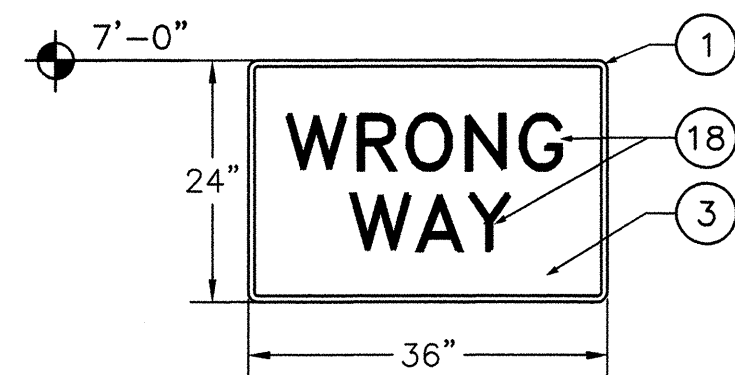


R5-9
36"x24"

7. WRONG WAY SIGN
C1.4 NOT TO SCALE CS.1

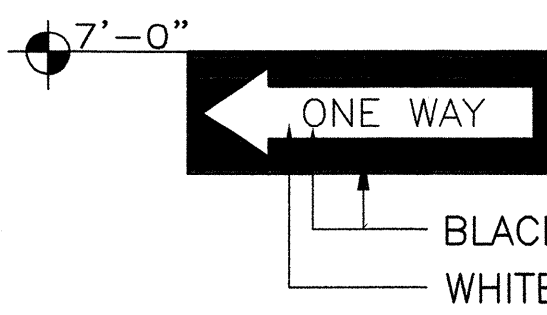


R6-1
36"x12"

8. ONE WAY SIGN
C1.4 NOT TO SCALE CS.1

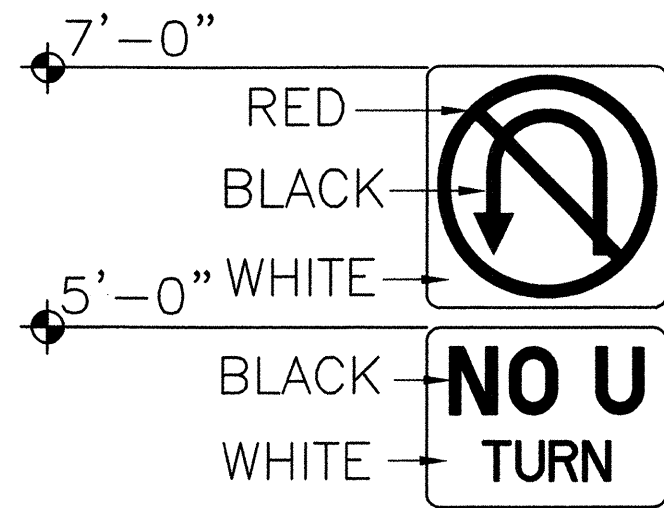


R3-4
24"x24"
24"x18"

9. NO U TURN SIGN
C1.3 NOT TO SCALE CS.1

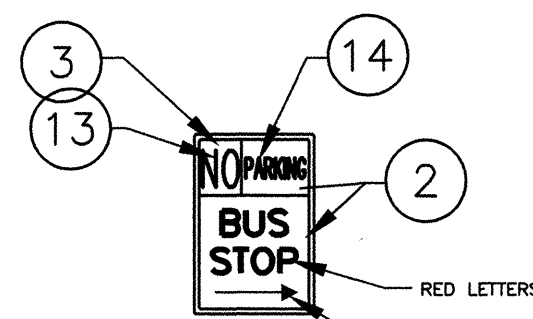


R7-107
12"x18"

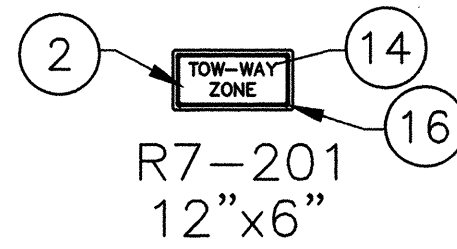


R7-201
12"x6"

10. NO PARKING/BUS STOP
C1.4 NOT TO SCALE CS.1

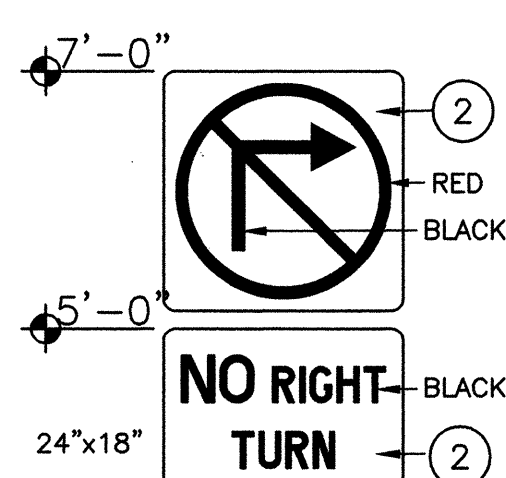

R3-1
24"x24"


11. NO RIGHT TURN SIGN
C1.4 NOT TO SCALE CS.1

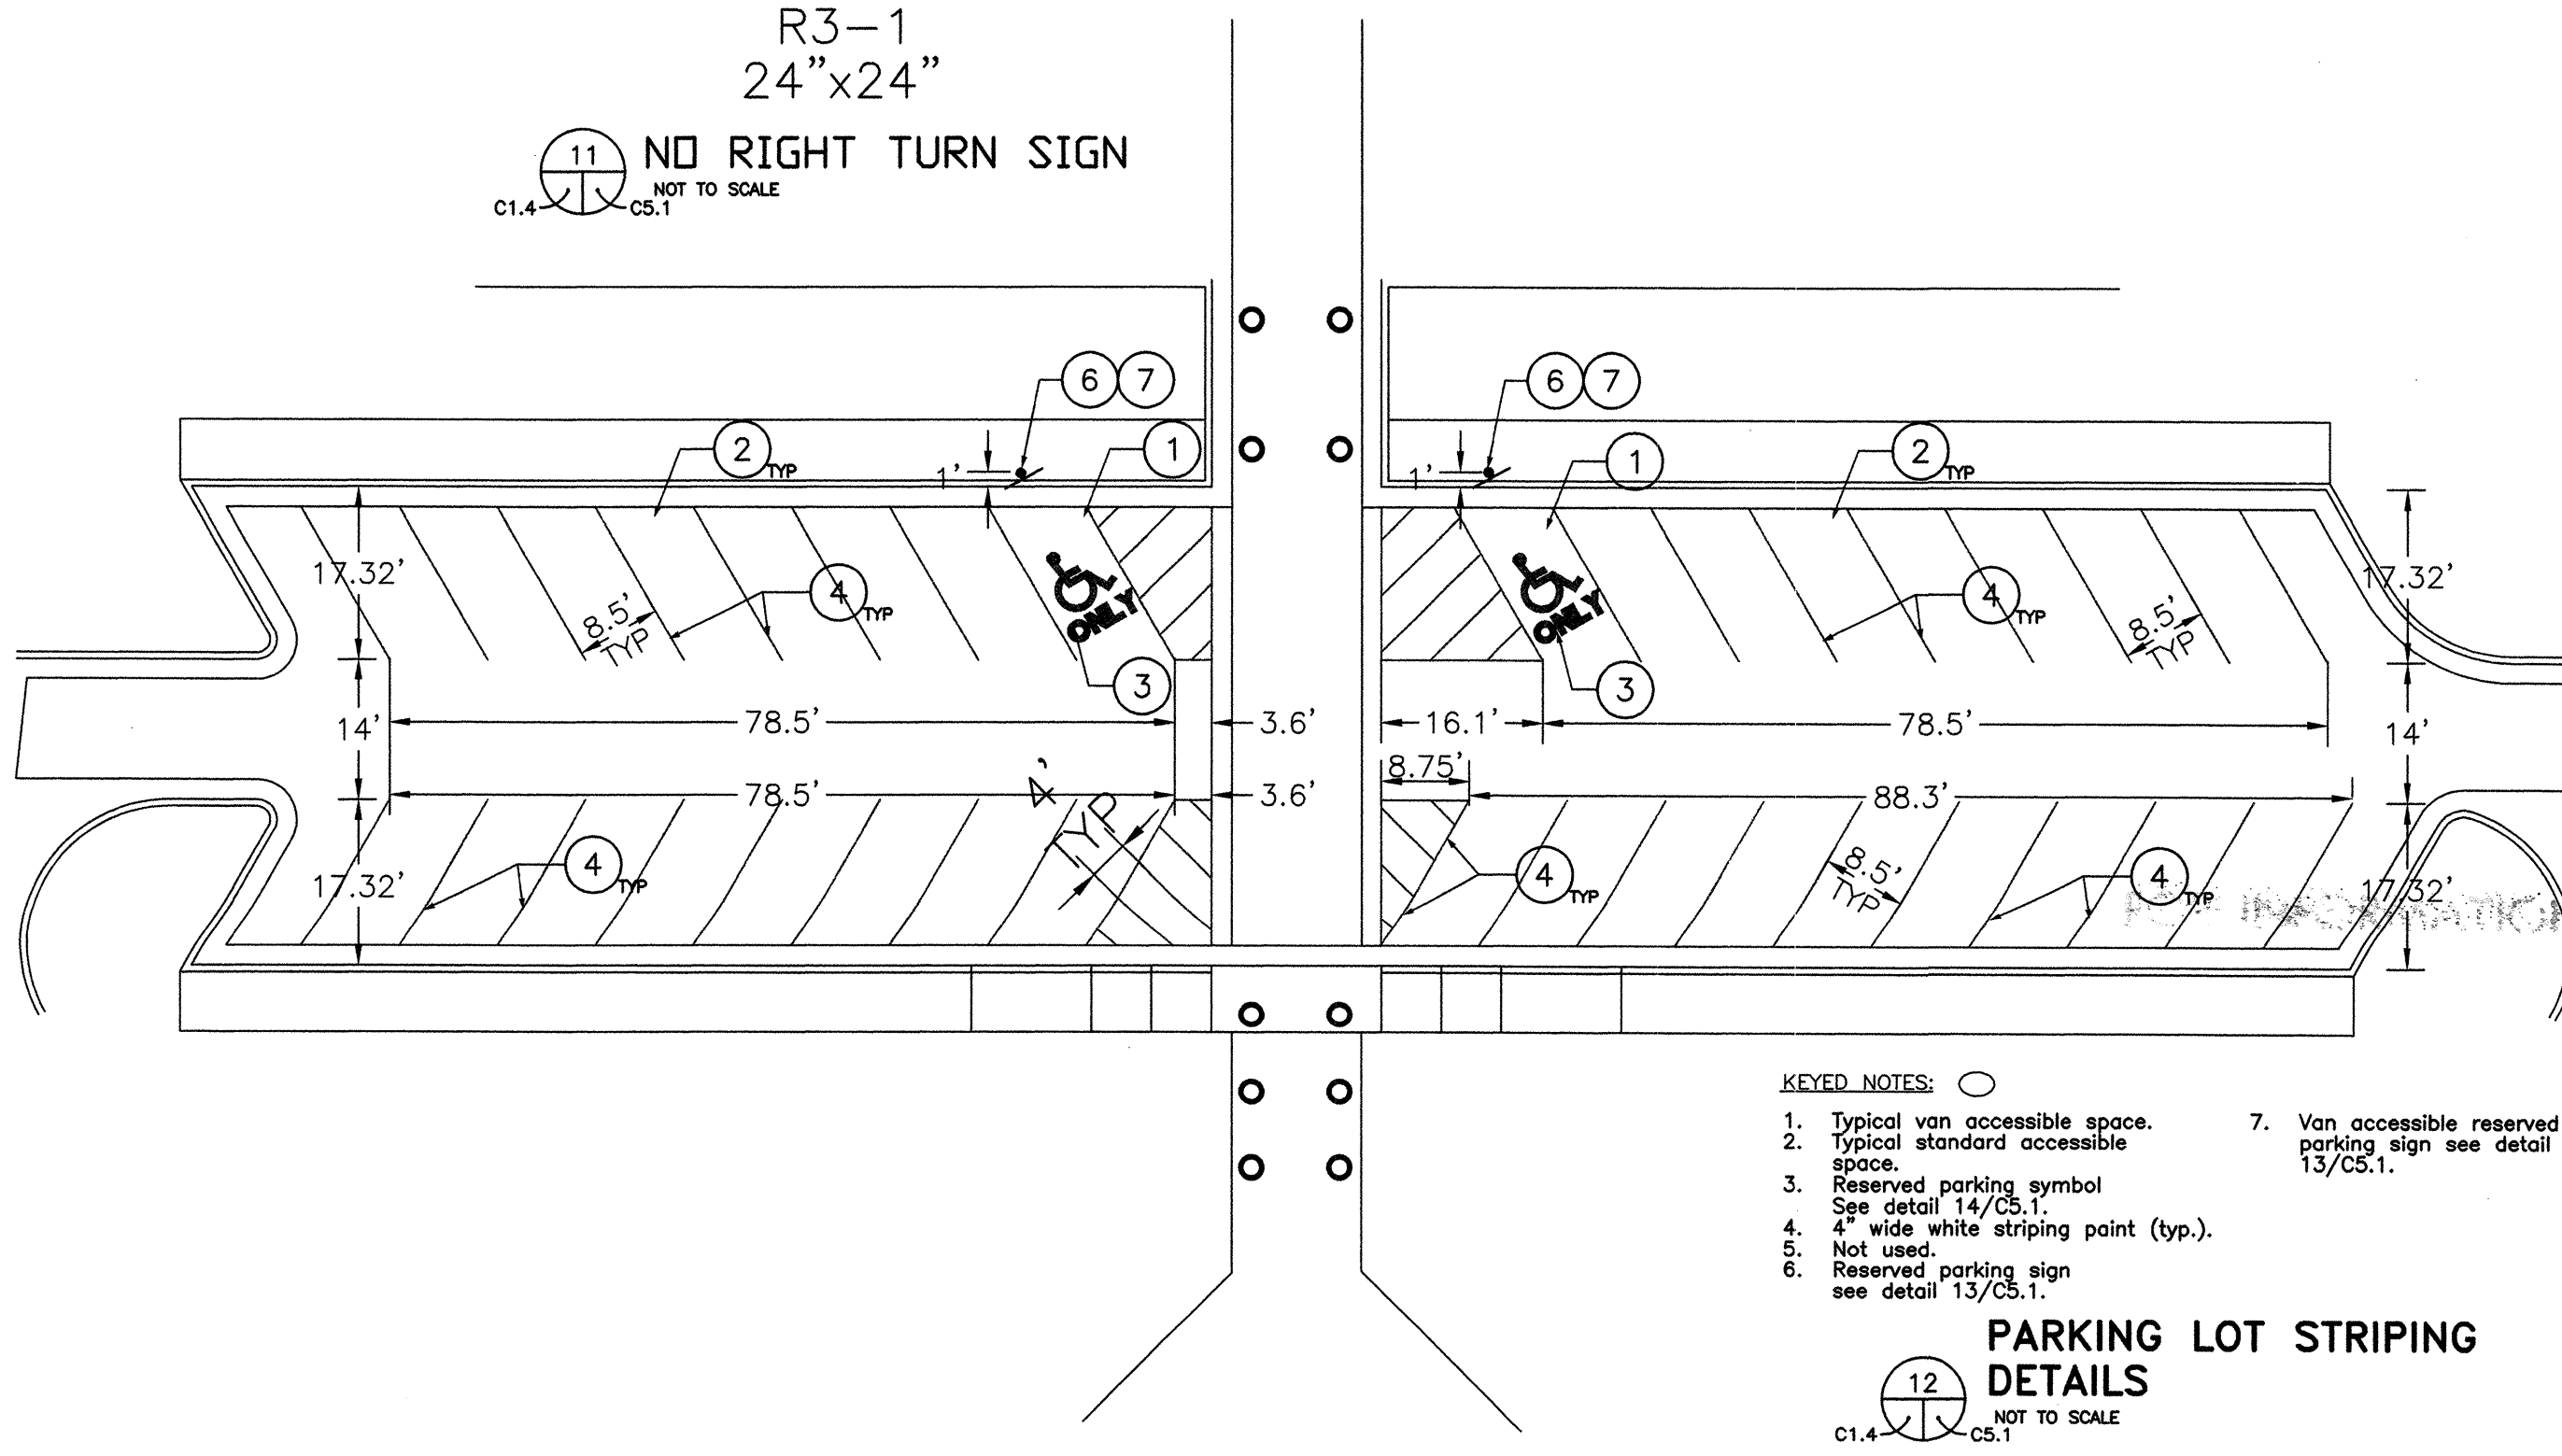

KEYED NOTES:


- Typical van accessible space.
- Typical standard accessible space.
- Reserved parking symbol See detail 14/CS.1.
- 4" wide white striping point (typ.).
- Not used.
- Reserved parking sign see detail 13/CS.1.
- Van accessible reserved parking sign see detail 13/CS.1.

12. PARKING LOT STRIPING DETAILS
C1.4 NOT TO SCALE CS.1

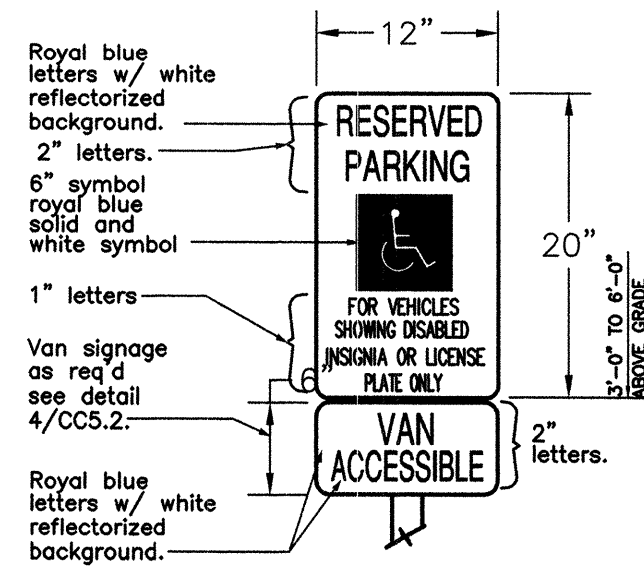

R7-8

13. RESERVED PARKING SIGN
C5.1 NOT TO SCALE CS.1

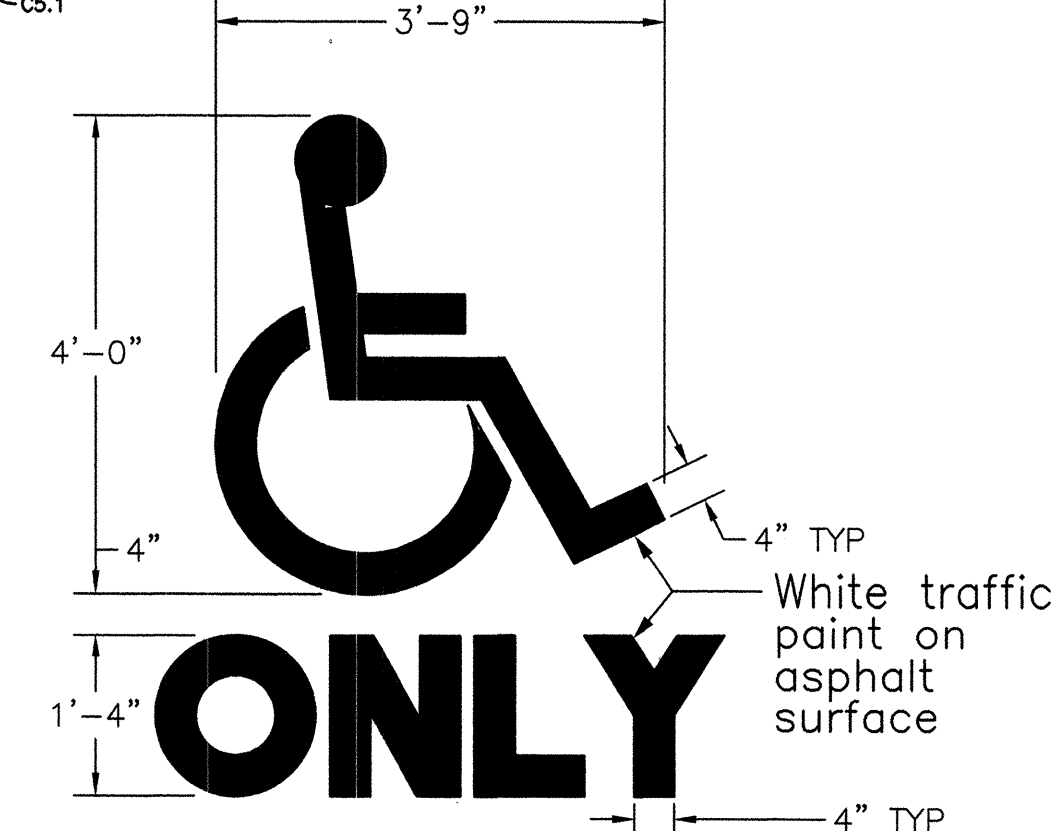

14. RESERVED PARKING SPACE SYMBOL
SCALE: 1/2" = 1'-0"

SIGNAGE KEYED NOTES:


- ONE INCH FILLET ON ALL CORNERS
- WHITE PAINTED BACKGROUND
- RED PAINTED BACKGROUND
- HELVETICA MEDIUM 4" WHITE VINYL LETTERS
- HELVETICA MEDIUM 3" BLACK VINYL LETTERS
- HELVETICA MEDIUM 2" BLACK VINYL LETTERS
- HELVETICA MEDIUM 1 1/2" BLACK VINYL LETTERS
- 3/8" WIDE BLACK VINYL STRIP, INSET 1" FROM SIGN EDGE
- RED PAINTED CIRCLE
- 3" WIDE BLACK VINYL ARROW IN DIRECTION OF TRAFFIC FLOW
- YELLOW PAINTED BACKGROUND
- WHITE BORDER
- WHITE LETTERS
- HELVETICA MEDIUM 2" RED VINYL LETTERS
- HELVETICA MEDIUM 1 1/2" RED VINYL LETTERS
- 3/8" WIDE RED VINYL STRIP, INSET 1" FROM SIGN EDGE
- BLACK BACKGROUND
- HELVETICA MEDIUM 6" WHITE VINYL LETTERS

NOTE:
FOR SIGN INSTALLATION REFER TO DETAIL.

TYPICAL TRAFFIC SIGNS

SIGNAGE SCHEDULE

- SIGNAGE SCHEDULE:
- SET POST IN CONCRETE TO A MINIMUM DEPTH OF 3'-0". USE A 2" STEEL FLANGED CHANNEL FOR SIGN POSTS. FABRICATE SIGN PANELS OF .063 ALUMINUM.
 - TEXT TO BE HELVETICA MEDIUM, UPPER AND LOWER CASE.
 - RED = PANTONE #485. BLUE = PANTONE #294.
 - NOT ALL SIGNS APPLY TO ALL PROJECTS.
 - LOCATE POSTS 1'-0" BACK FROM ADJACENT CURBS, UNLESS NOTED OTHERWISE.
 - ALL 2" FLANGED CHANNEL SIGN POSTS TO BE INSTALLED WITH BREAK AWAY CONNECTION.
 - ALL SIGNS TO HAVE AN ANTI-GRAFFITI COATING, BOTH SIDES.

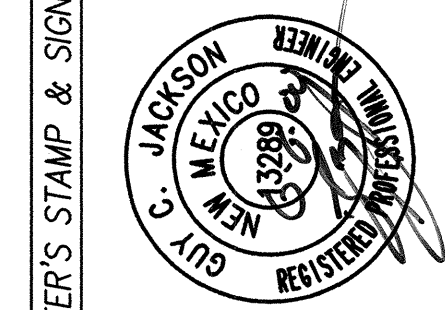

BPLW




Architects & Engineers, Inc.
8200 Uptown Blvd. NE
Suite 400
Albuquerque, New Mexico 87110
(505) 861-2799

49 West First Street
Suite 100
Albuquerque, New Mexico 87102
(505) 827-2799

Designing to Shape the Future

CITY OF ALBUQUERQUE
PUBLIC WORKS DEPARTMENT
ENGINEERING DEVELOPMENT GROUP

TITLE: CONSOLIDATED RENTAL CAR FACILITY
SERVICE CENTER AREA

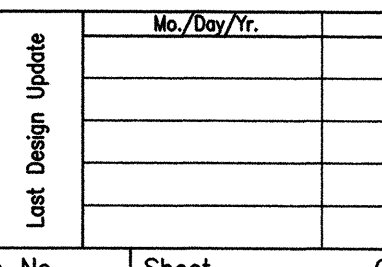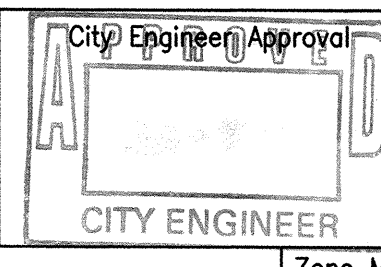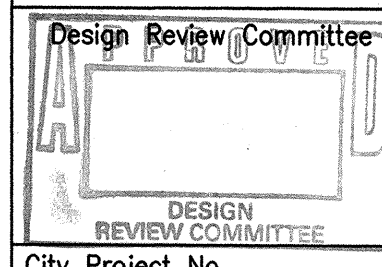


City Project No. 6101.98


Zone Map No. N-15-Z

Sheet C5.1 Of

ELECTRICAL SYMBOL LEGEND	
SYMBOL	DESCRIPTION
⊙	JUNCTION BOX
⎓→	CONDUCTOR TYPE INDICATION AND CIRCUIT HOMERUN:
—	120/208V, 3 PHASE, 4 WIRE ELECTRICAL PANEL

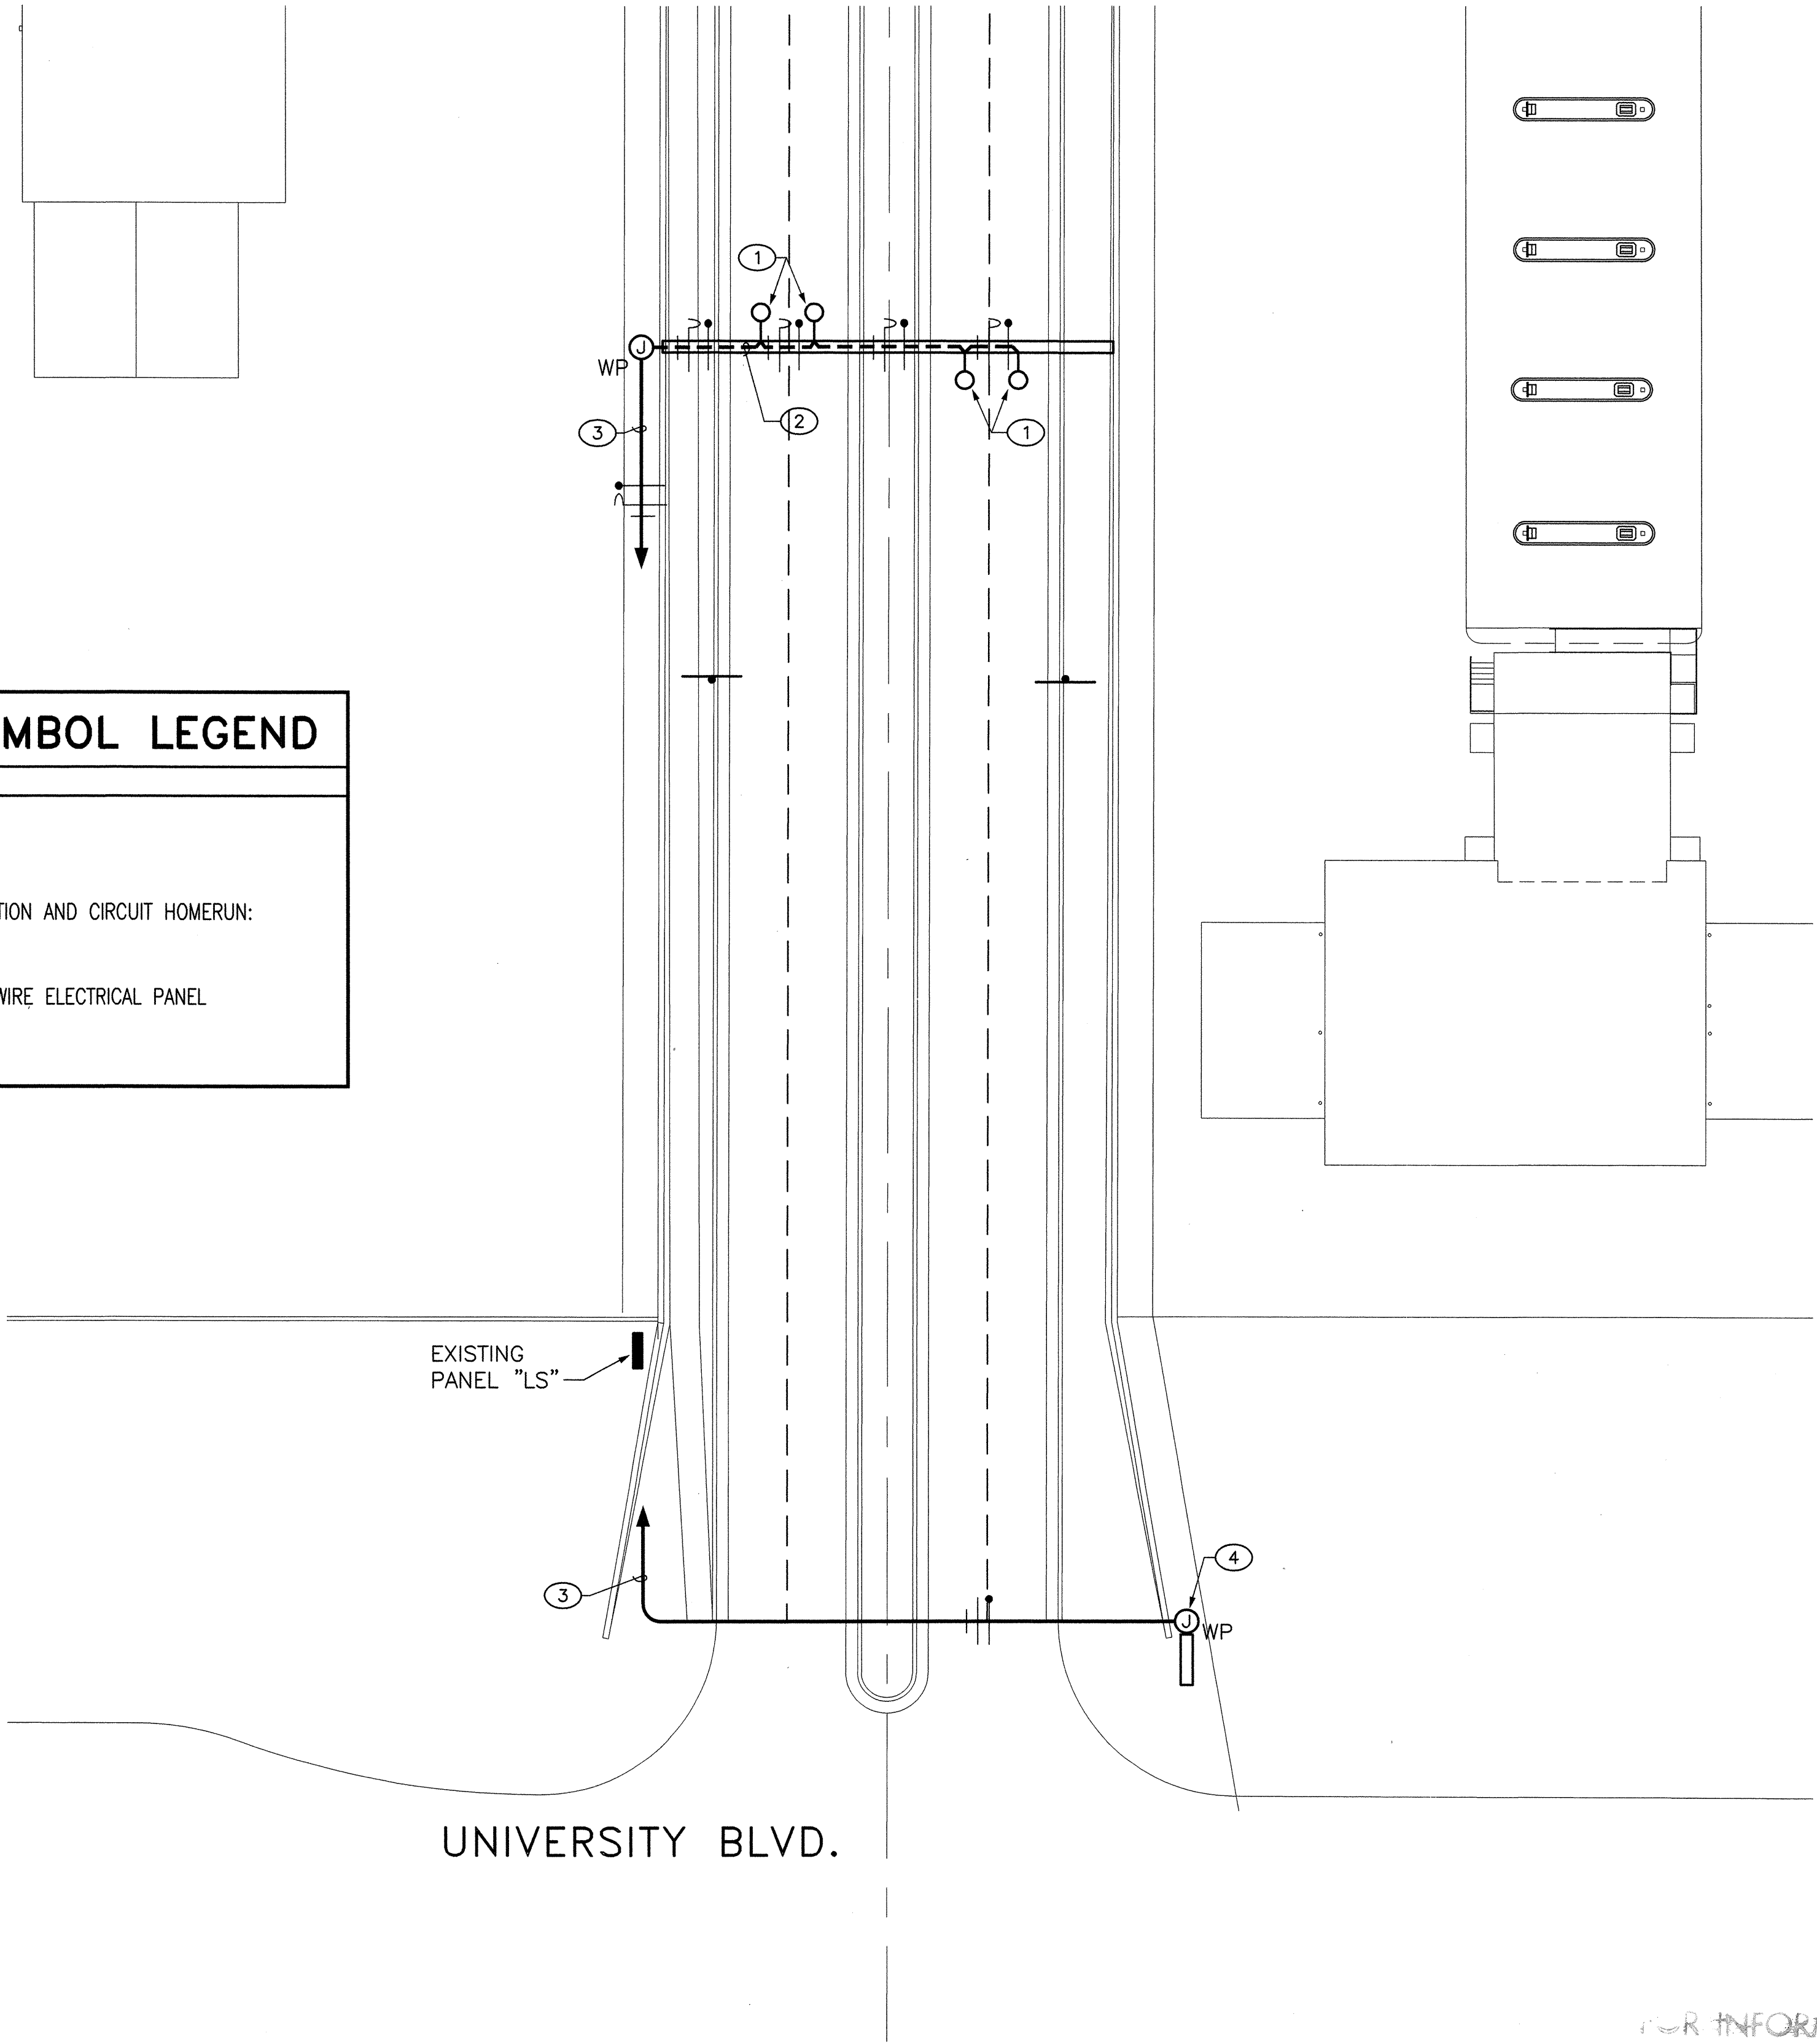


- KEYED NOTES:** ○
- 175W H.I.D. FLOODLIGHT MOUNTED ON 36"x2" DIA. STEEL PIPE WELDED TO BOTTOM CHORD OF STEEL TRUSS. GE FIXTURE MODEL #V2FN-175M-0-H-1-P-SN4-GR WITH 1-175W CLEAR METAL HALIDE LAMP.
 - 2-#10 & 1-#10 GRD. IN 1/2"C. ROUTE CONDUIT ON TOPSIDE OF THE CURVED TOP CHORD OF SIGN TRUSS, THEN DOWN BEHIND SIGN TO LIGHT FIXTURES. PAINT CONDUIT TO MATCH SIGN TRUSS.
 - 2-#10 & 1-#10 GRD. IN 3/4"C. TO 20A-1P BREAKER IN PANEL "LS". CIRCUIT SHALL BE CONTROLLED BY A 2000W, 120V PHOTOCELL MOUNTED ON NORTH SIDE OF SIGN TRUSS.
 - WEATHERPROOF JUNCTION BOX FOR CONNECTION TO INTERNALLY ILLUMINATED MONUMENT SIGN.

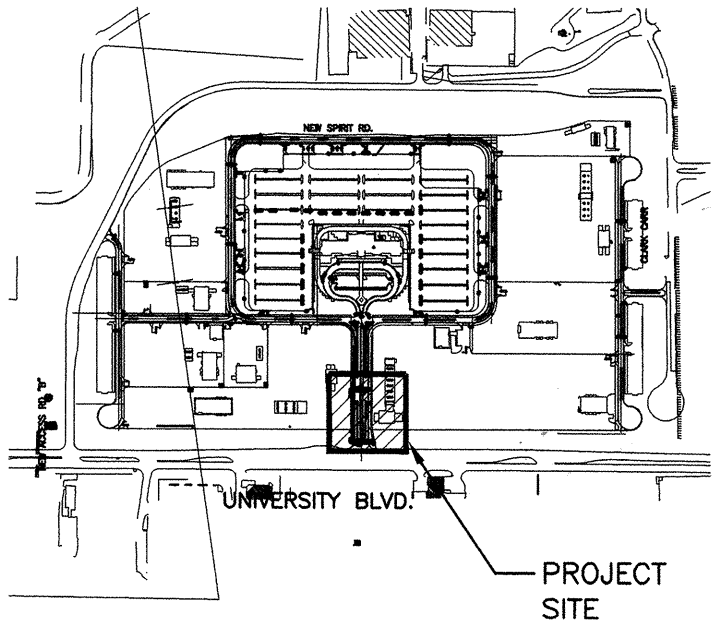

BPLW
Architects & Engineers, Inc.
6250 Uptown Blvd. NE
Suite 400
Albuquerque, New Mexico 87110
(505) 981-2759
Designing to Shape the Future

49 West First Street
Suite 100
Mesa, Arizona 85201
(602) 837-2799

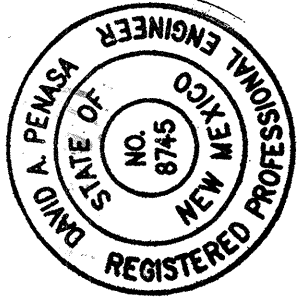

CITY OF ALBUQUERQUE PUBLIC WORKS DEPARTMENT ENGINEERING DEVELOPMENT GROUP	
TITLE: CONSOLIDATED RENTAL CAR FACILITY CUSTOMER SERVICE BUILDING SIGN LIGHTING PLAN - MAIN ENTRANCE	
Design Review Committee REVIEW COMMITTEE	City Engineer
City Project No. —	Zone Map No. N-15-Z
Sheet Of	ES.2 2