

AUGUST 2, 1999

CONSTRUCTION DOCUMENTS

CLASS II CONSTRUCTION

MARY FOX PARK
Play Area Renovation

INDEX OF DRAWINGS

TITLE


- COVER SHEET
- SITE PLAN AND CONSTRUCTION DETAILS
- LAYOUT PLAN AND PLAY AREA PLAN
- IRRIGATION PLAN

SHEET NO.

- CS OF 4
- L1 OF 4
- L2 OF 4
- L3 OF 4

FOR INFORMATION ONLY

DESIGNWORKSHOP
901 Rio Grande NW
Suite E130
Albuquerque, NM 87104
(Tel.) 505.243.8333
(Fax) 505.243.8337

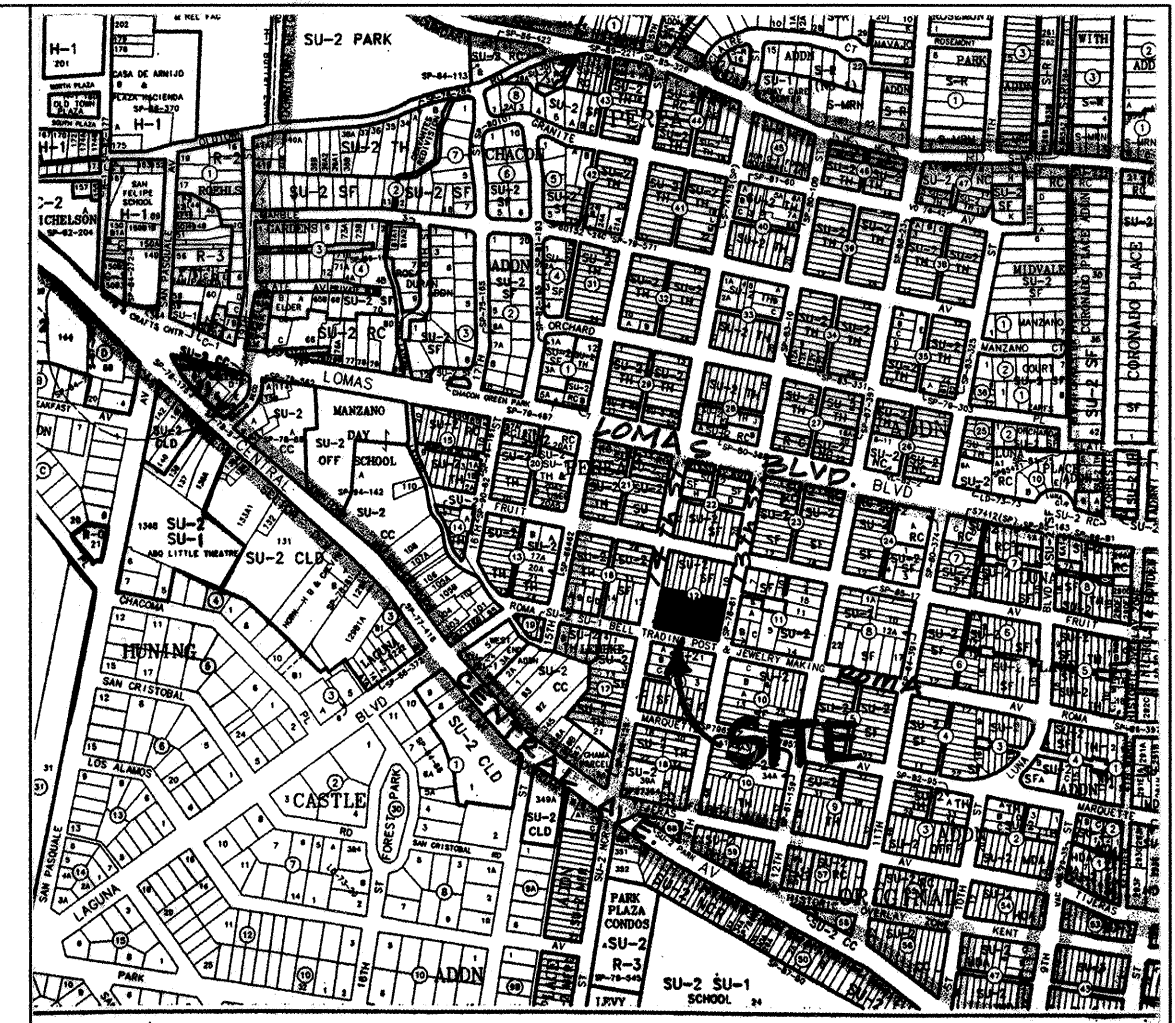

- LOCATION MAP J-13-Z
- ALL WORK TO BE IN ACCORDANCE WITH CITY OF ALBUQUERQUE STANDARD SPECIFICATIONS, 1986 EDITION (AS UPDATED WITH REVISION #6).
 - THE WATER SYSTEMS DIVISION (857-8200) SHALL BE NOTIFIED (5) FIVE WORKING DAYS IN ADVANCE OF ANY WORK WHICH MAY AFFECT EXISTING PUBLIC WATER FACILITIES. THE CONTRACTOR SHALL ALSO COORDINATE FOR VALVE OPERATION FOR WATER SHUTOFF.
 - (5) FIVE WORKING DAYS PRIOR TO BEGINNING CONSTRUCTION CONTRACTOR SHALL SUBMIT TO THE CONSTRUCTION COORDINATION DIVISION A DETAILED CONSTRUCTION SCHEDULE. REFER TO SECTION 19 OF THE CITY OF ALBUQUERQUE STANDARD SPECIFICATIONS.
 - (2) TWO WORKING DAYS PRIOR TO CONSTRUCTION THE CONTRACTOR SHALL OBTAIN A BARRICADING PERMIT FROM THE CONSTRUCTION COORDINATION DIVISION. CONTRACTOR SHALL NOTIFY BARRICADE ENGINEER (768-2551) PRIOR TO OCCUPYING AN INTERSECTION. SEE SECTION 19 OF THE CITY OF ALBUQUERQUE STANDARD SPECIFICATIONS.
 - ALL STREET STRIPING ALTERED OR DESTROYED SHALL BE REPLACED IN KIND BY CONTRACTOR TO LOCATION AND IN KIND AS EXISTING OR AS INDICATED BY THIS PLAN SET.
 - THE CONTRACTOR SHALL CONTACT NEW MEXICO ONE CALL SYSTEM PHONE: 260-1990, TO LOCATE UNDERGROUND UTILITIES 2 WORK DAYS PRIOR TO BEGINNING EXCAVATION.
 - THE CONTRACTOR SHALL CONTACT TRAFFIC ENGINEERING OPERATIONS 857-8680 FOR REMOVAL AND REPLACEMENT OF TRAFFIC SIGNS.
 - THE CONTRACTOR SHALL PROTECT ALL EXISTING UTILITIES, UNLESS NOTED OTHERWISE. ANY DAMAGE TO EXISTING UTILITIES SHALL BE REPAIRED AT THE CONTRACTOR'S EXPENSE.
 - THE CONTRACTOR SHALL ASSUME RESPONSIBILITY FOR ANY DAMAGE TO EXISTING PAVEMENTS, PAVEMENT MARKINGS, CURB AND GUTTER, DRIVEPADS, WHEELCHAIR RAMPS AND SIDEWALKS DURING CONSTRUCTION APART FROM THOSE SECTIONS INDICATED FOR REMOVAL ON THE PLANS AND SHALL REPAIR OR REPLACE PER CITY OF ALBUQUERQUE STANDARD AT HIS OWN EXPENSE.
 - PRIOR TO CONSTRUCTION, THE CONTRACTOR SHALL CHECK ALL DIMENSIONS, HORIZONTAL AND VERTICAL, AND SHALL EXCAVATE AND VERIFY THE HORIZONTAL AND VERTICAL LOCATIONS OF ALL OBSTRUCTIONS. SHOULD A CONFLICT EXIST, THE CONTRACTOR SHALL NOTIFY THE ENGINEER PRIOR TO CONSTRUCTION SO THAT CONFLICT CAN BE RESOLVED WITH THE MINIMUM AMOUNT OF DELAY.
 - FOR PURPOSES OF THIS PROJECT THE TERM ENGINEER SHALL REFER TO EITHER THE OWNER'S EMPLOYEE THE ARCHITECT OR THE LANDSCAPE ARCHITECT RESPONSIBLE FOR CONSTRUCTION INSPECTION OF THE PROJECT.
 - ALL REFERENCES TO COMPACTED BACKFILL OR COMPACTED SUBGRADE SHALL MEAN SOIL COMPACTED TO 95% OF MAXIMUM DENSITY AS DETERMINED BY ASTM D-1557 UNLESS OTHERWISE NOTED.
 - CONTRACTOR SHALL NOTIFY THE ENGINEER NOT LESS THAN SEVEN (7) DAYS PRIOR TO STARTING WORK, IN ORDER THAT THE ENGINEER MAY TAKE NECESSARY MEASURES TO INSURE THE PRESERVATION OF SURVEY MONUMENTS. CONTRACTOR SHALL NOT DISTURB PERMANENT SURVEY MONUMENTS WITHOUT THE CONSENT OF THE ENGINEER AND SHALL NOTIFY THE ENGINEER AND BEAR THE EXPENSE OF REPLACING ANY THAT MAY BE DISTURBED WITHOUT PERMISSION. REPLACEMENT SHALL BE DONE ONLY BY THE CITY OF ALBUQUERQUE SURVEY SECTION. WHEN A CHANGE IS MADE IN THE FINISH ELEVATION OF THE PAVEMENT OF ANY ROADWAY IN WHICH A PERMANENT SURVEY MONUMENT IS LOCATED, CONTRACTOR SHALL, AT HIS OWN EXPENSE, ADJUST THE MONUMENT COVER TO NEW GRADE, UNLESS OTHERWISE SPECIFIED.

REV.	SHEETS	CITY ENGINEER	DATE	USER DEPARTMENT	DATE	USER DEPARTMENT	DATE
LANDSCAPE ARCHITECT'S SEAL	APPROVALS	ENGINEER	DATE	*****	APPROVED FOR CONSTRUCTION		
	DCR Chairman	<i>[Signature]</i>	9-7-99				
	Transportation	<i>[Signature]</i>	8-18-99				
	Water/Wastewater	<i>[Signature]</i>	8-18-99				
	Hydrology	<i>[Signature]</i>	8-18-99				
	CONSTR. MGMT.	<i>[Signature]</i>	8-23-99				
	City Project Number	620691		Sheet	CS	Of	16



SET NUMBER: _____




NOTES:

- INSTALL POSTS & COMPONENTS PER MANUFACTURER'S SPECIFICATIONS
- PLAY VENTURE POSTS TO BE RED

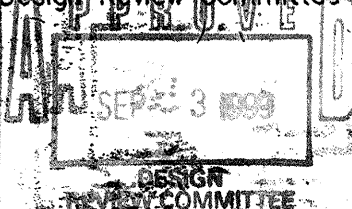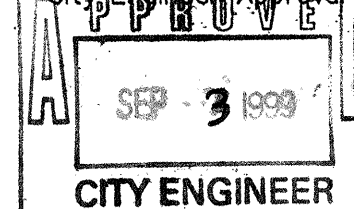



CITY OF ALBUQUERQUE PUBLIC WORKS DEPARTMENT ENGINEERING DEVELOPMENT GROUP			
TITLE: MARY FOX PARK PLAY AREA RENOVATION LAYOUT PLAN & PLAY AREA PLAN			
Design Review Committee 	City Engineer Approval 	Last Design Update	Mo./Day/Yr.
			Mo./Day/Yr.
			Mo./Day/Yr.
City Project No. 620691	Zone Map No. T 15 3	Sheet 16	Of 16

[illegible]

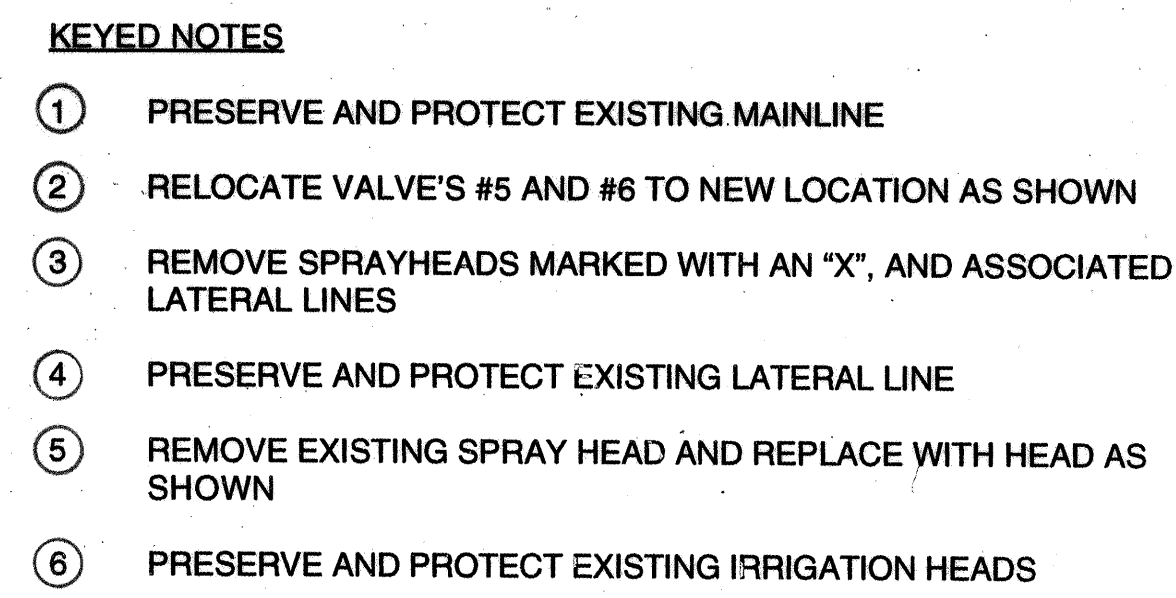

- LEGEND (EXISTING SYSTEM)
4. ☐ ☐ WEATHER-MATIC SUPER-POP SPRAY HEAD - BRONZE BODY W/ 5/20 NOZZLE UNLESS OTHERWISE NOTED.
4. ☐ ☐ " " " 1/4 F.H.Q. NOZZLE ON T3 ADAPTOR
4. ☐ ☐ " " " BUBBLER HEAD+105
4. ☐ ☐ RAIN-O-MAT ROTARY POP-UP SPRINKLER W/ RUBBER COVER 9F, 9H, 9Q
- ☐ WEATHER-MATIC ELECTRO-VAL 2000 SERIES REMOTE CONTROL VALVE
- ☒ " " " SER IO CONTROLLER - TO BE PLACED IN CONCRETE HOUSING PROVIDED BY CITY.
- LATERALS - CLASS 200 PVC
- MAIN LINE - (NON-PRESSURE) SCHEDULE 40 PVC
- ☐ PE80 MOD 805 - DOUBLE CHECK BACKFLOW PREVENTER OR APPROVED EQUAL - PROVIDE BASE AND HAYES OR EQ. CALV. COR. 3/4" &
- ☐ WEATHER-MATIC - 1 ELECTRO-VAL MASTER VALVE 200-B FAK 212" SHELL W/G.I. LOCKING COVER

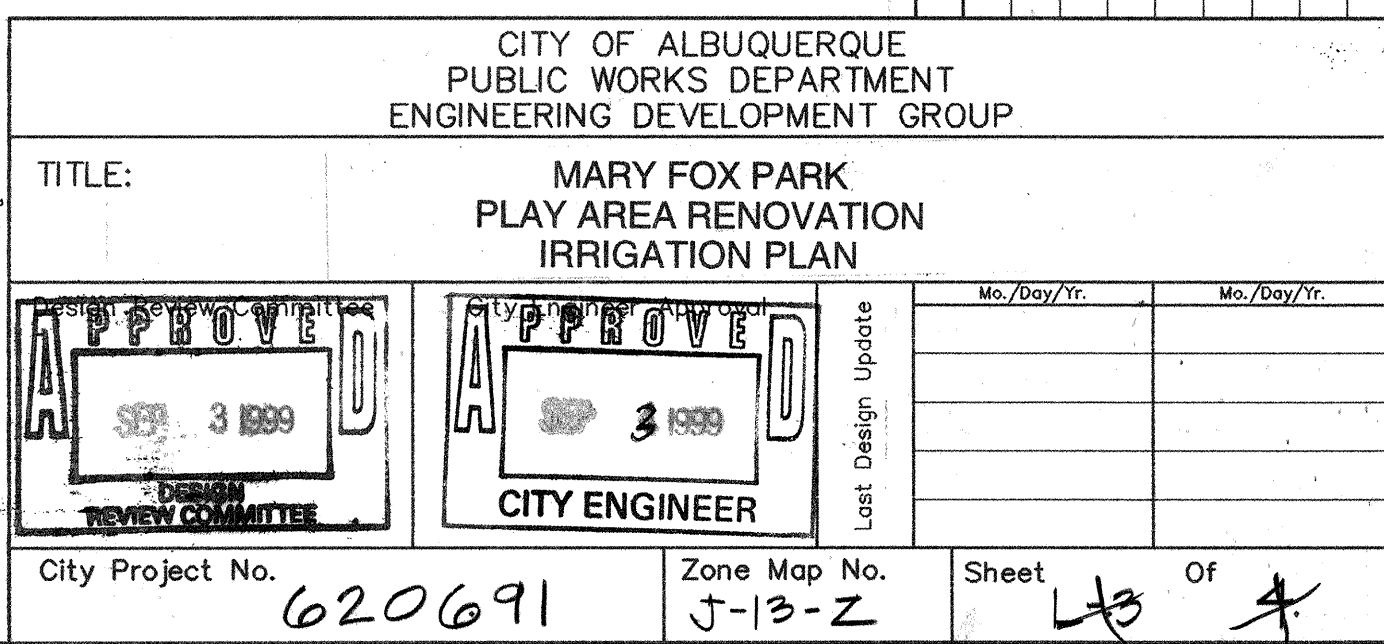[illegible]

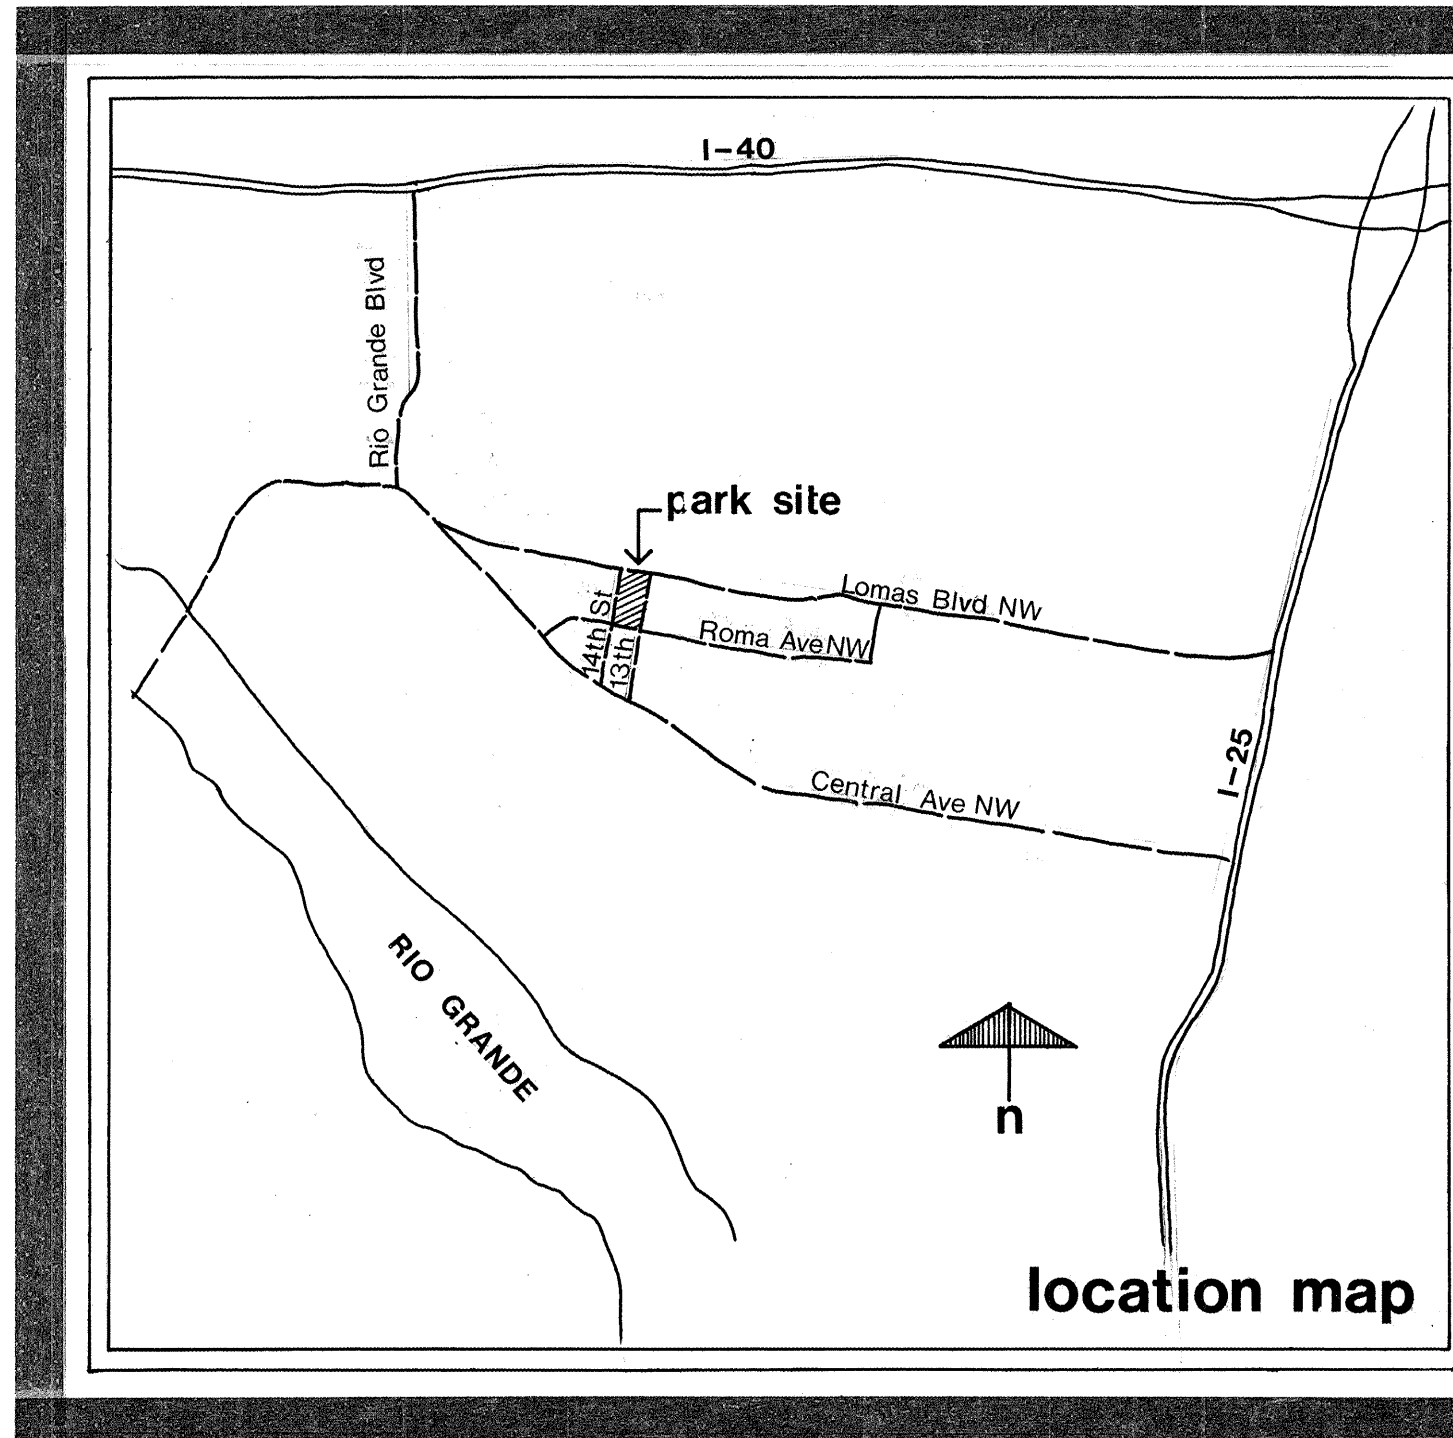

MARY FOX PARK
COMMUNITY DEVELOPMENT PROJ. A-26C

city of albuquerque
urban development agency

FOR INFORMATION ONLY


craig campbell - associates
LANDSCAPE ARCHITECTS SITE PLANNERS

SANTA FE 471-0851 ALBUQUERQUE 242-9928

ELECTRICAL CONSULTANTS: TIERRA DEL SOL ENGINEERING
ALBUQUERQUE, N.M. 293-9250

INDEX TO DRAWINGS

- 1 COVER SHEET
- 2 EXISTING CONDITIONS
- 3 STAKING PLAN
- 4 GRADING PLAN
- 5 PLANTING PLAN
- 6 IRRIGATION PLAN
- 7 ELECTRICAL PLAN
- 8 PERGOLA PLAZA DETAILS
- 9 SITE DETAILS

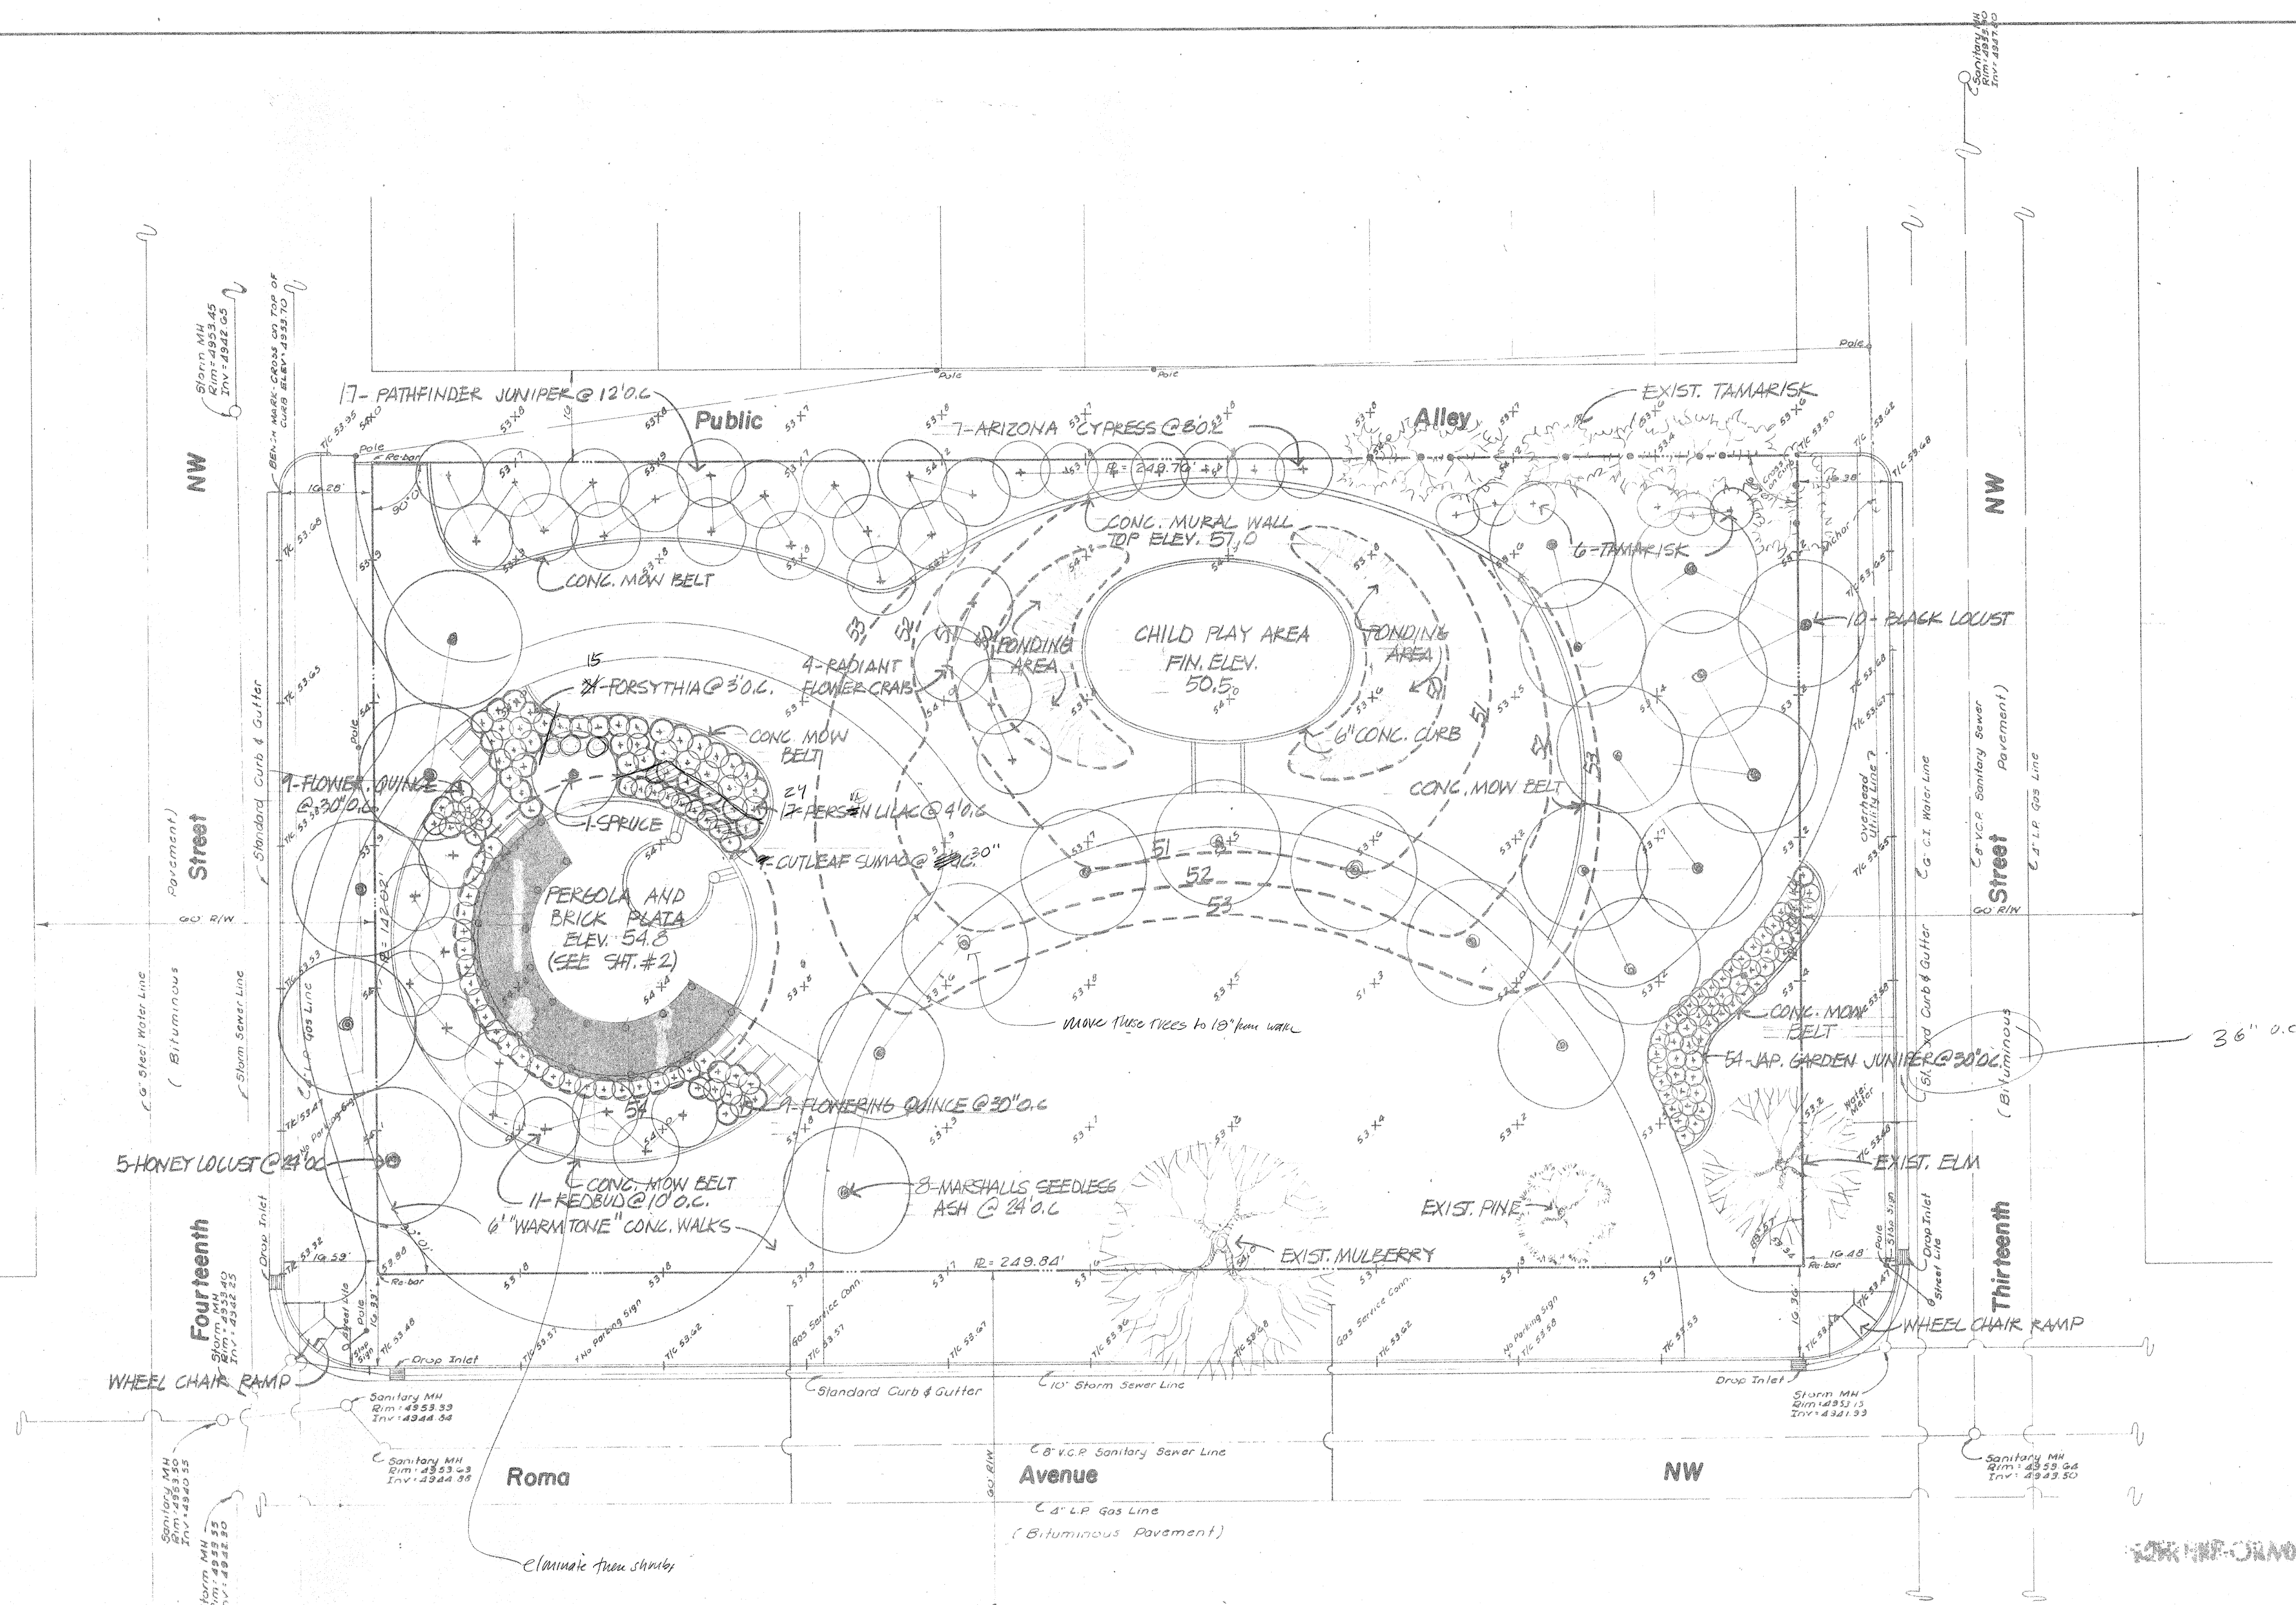

FOR INFORMATION ONLY

MARY FOX PARK - DESIGN DEVELOPMENT PLAN


[illegible]

craig
campbell
associates



landscape architects
site planners.



ALBUQUERQUE - SANTA FE

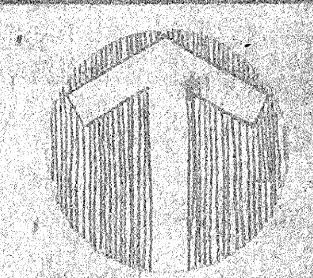

SCALE: $1'' = 16'$
DATE: 7-10-78
DRAWN: M.W.
CHECKED: C.C.

SHEET NUMBER

 1

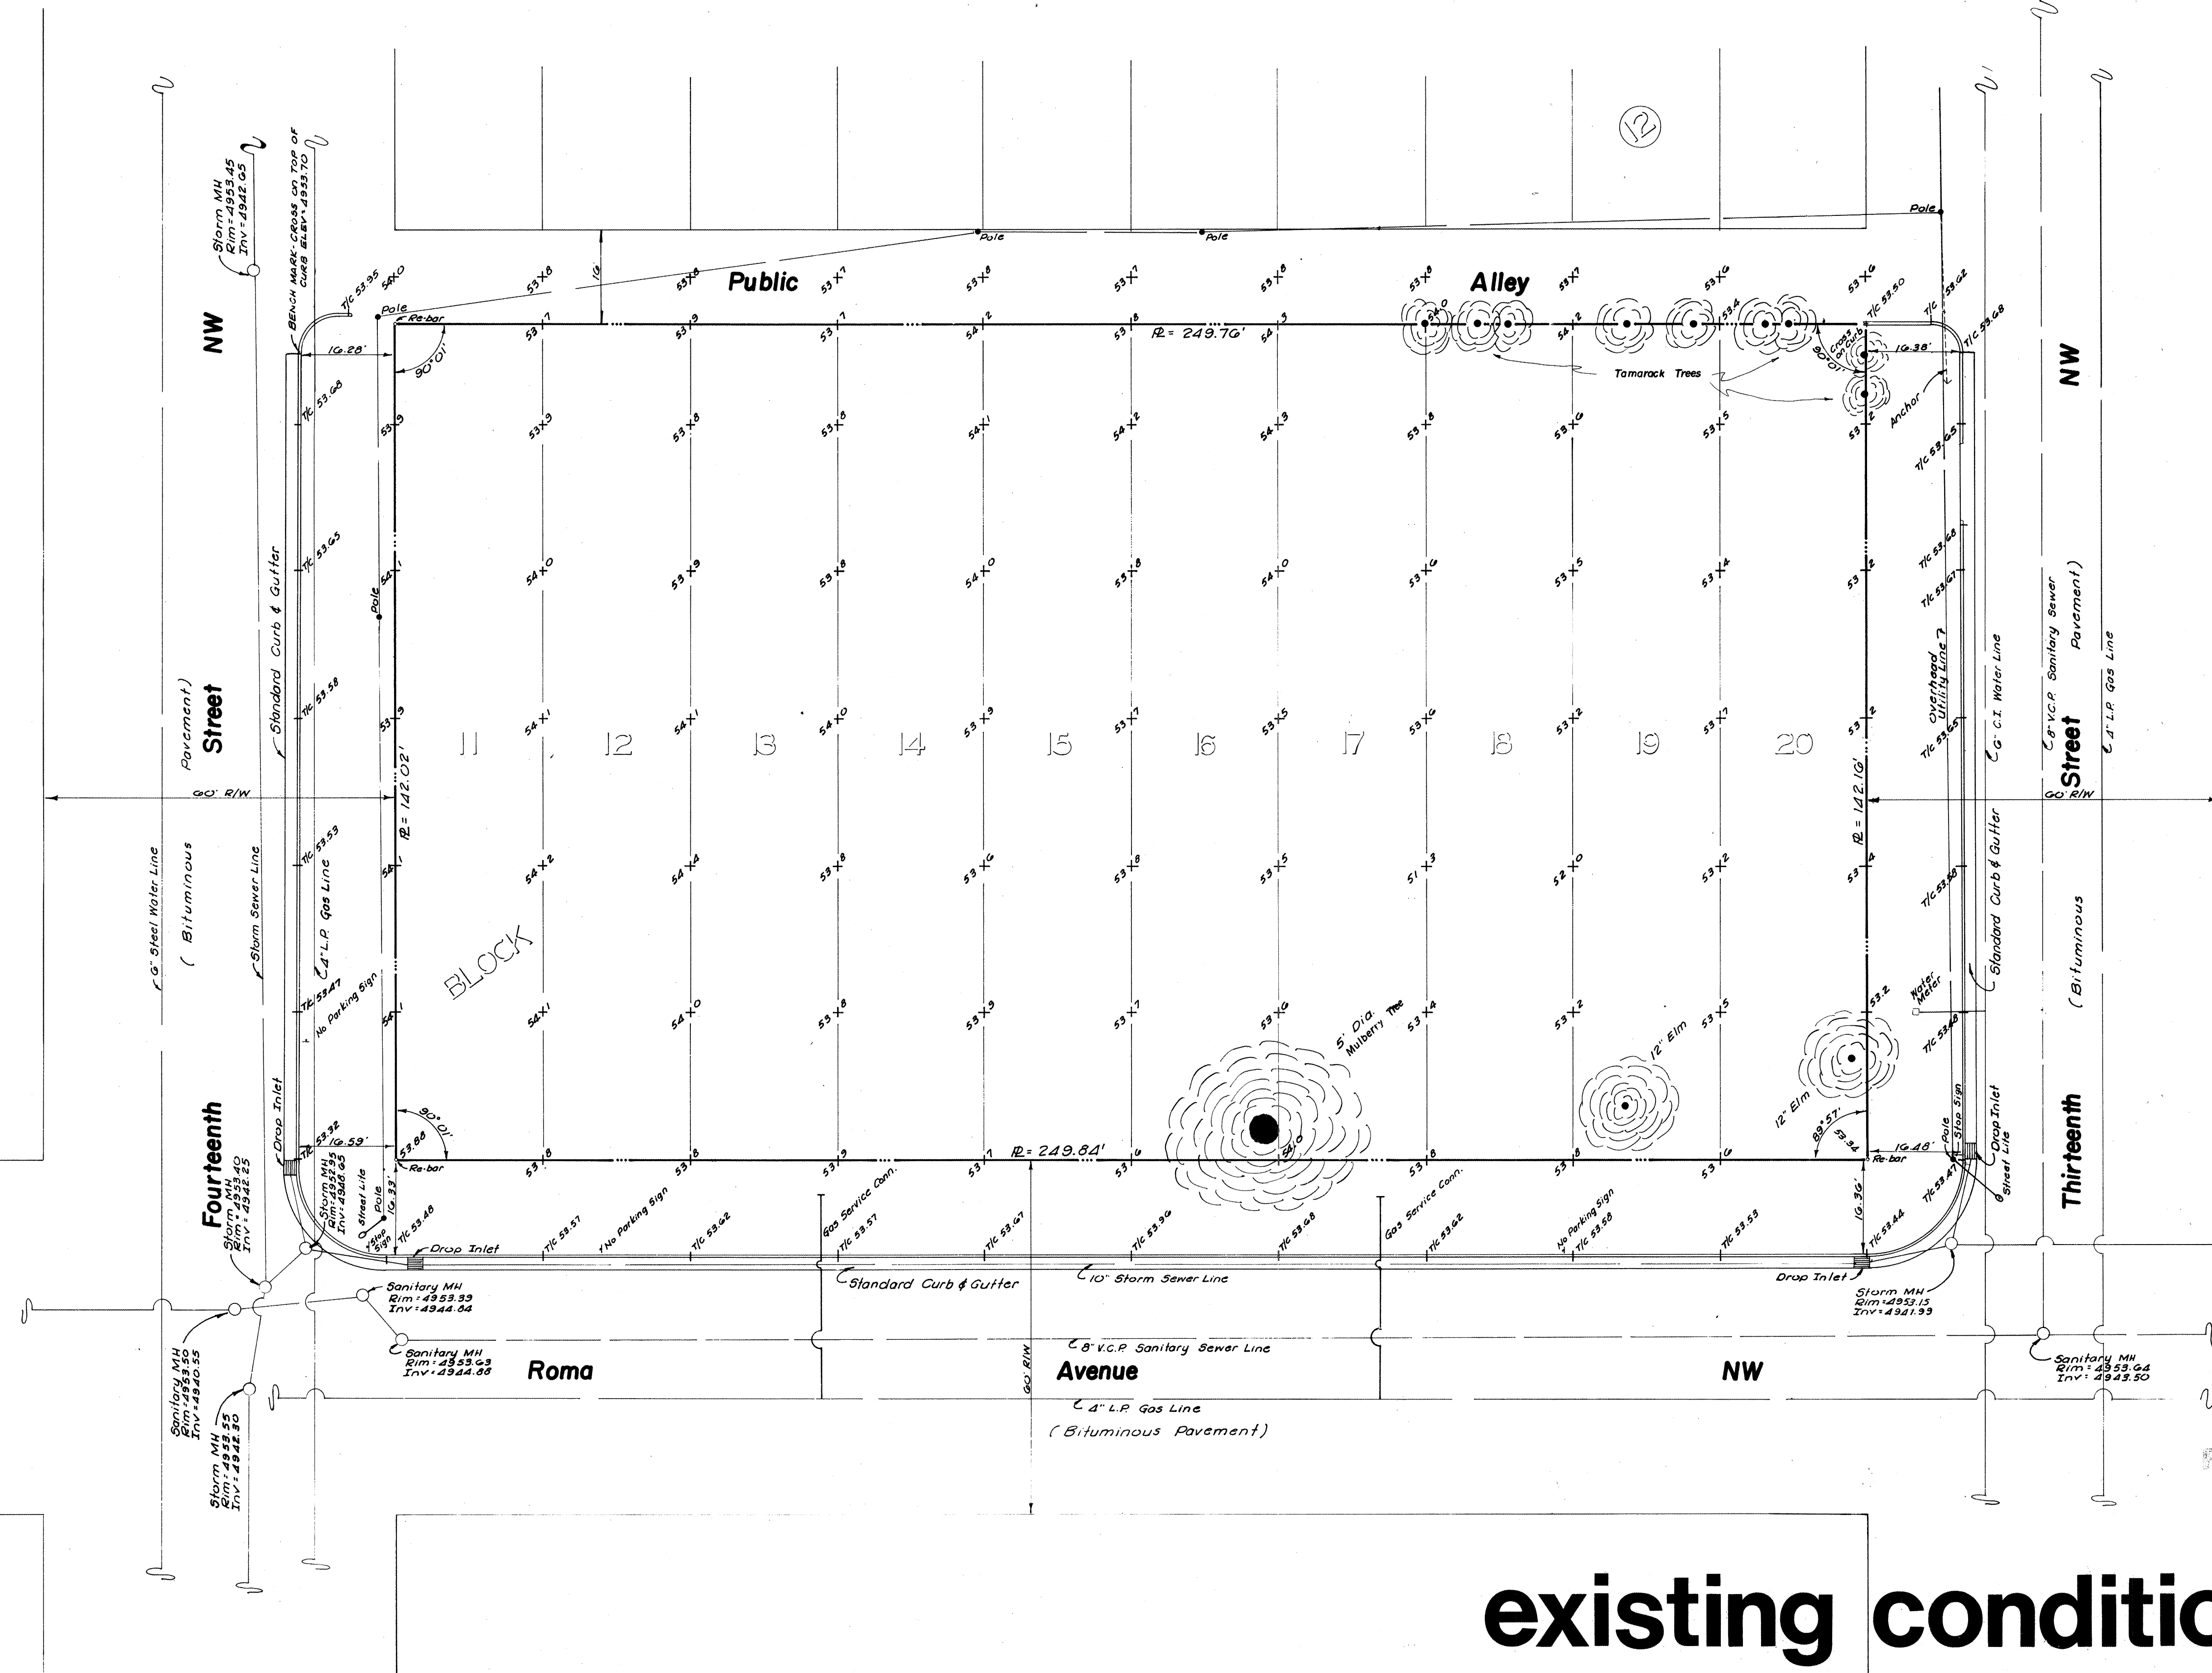

FOR INFORMATION ONLY

existing conditions plan

LEGAL DESCRIPTION:

Lots numbered Eleven (11) thru Twenty (20) of Block numbered Twelve (12) of the PEREA ADDITION to the City of Albuquerque, New Mexico, as the same is shown and designated on the map of said Addition filed in the office of the Probate Clerk and Ex-officio Recorder of Bernalillo County, New Mexico, on the 1st day of May, 1891.

NOTE:

Water, Sanitary Sewers, Storm Sewers and Gas Lines are from records from the City of Albuquerque Engineering Department and the Gas Company of New Mexico.

PLAT SHOWING
GRID ELEVATIONS and IMPROVEMENTS of
LOTS ELEVEN (11) thru TWENTY (20)

BLOCK 12
OF THE
PEREA ADDITION
TO THE CITY OF
ALBUQUERQUE, NEW MEXICO

ROSS HOWARD COMPANY - ALBUQUERQUE, NEW MEXICO

SCALE 1" = 16'


DRK-MDJ-RH

MAY 1, 1978

CITY ZONE ATLAS NO. J-13-Z

SURVEYORS CERTIFICATE

I, David R. Kraemer, a duly qualified Land Surveyor licensed to practice under the laws of the State of New Mexico, do hereby certify that the plat hereon delineated was prepared from the field notes of an actual physical survey made in the field under my direction and supervision and that the representations thereon are true and correct to the best of my knowledge and belief.

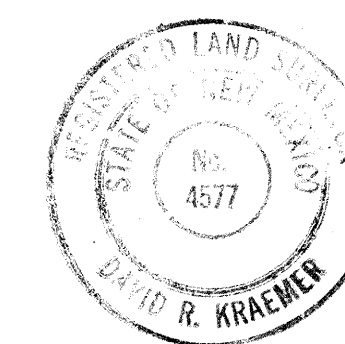

By David R. Kraemer
DAVID R. KRAEMER
New Mexico Registered
Land Surveyor No. 4577

REVISIONS

craig
campbell
associates
landscape architects
site planners

ALBUQUERQUE · SANTA FE

SCALE: 1/16" = 1'-0"

DATE:

DRAWN:

CHECKED:

SHEET NUMBER

2

6206.91 7 of 16

REVISIONS

MARY FOX
PARK
Albuquerque

craig
campbell
associates
landscape architects
site planners

ALBUQUERQUE · SANTA FE


SCALE:
DATE:
DRAWN:
CHECKED:


SHEET NUMBER

2



grading plan

6206.71 8 of 10

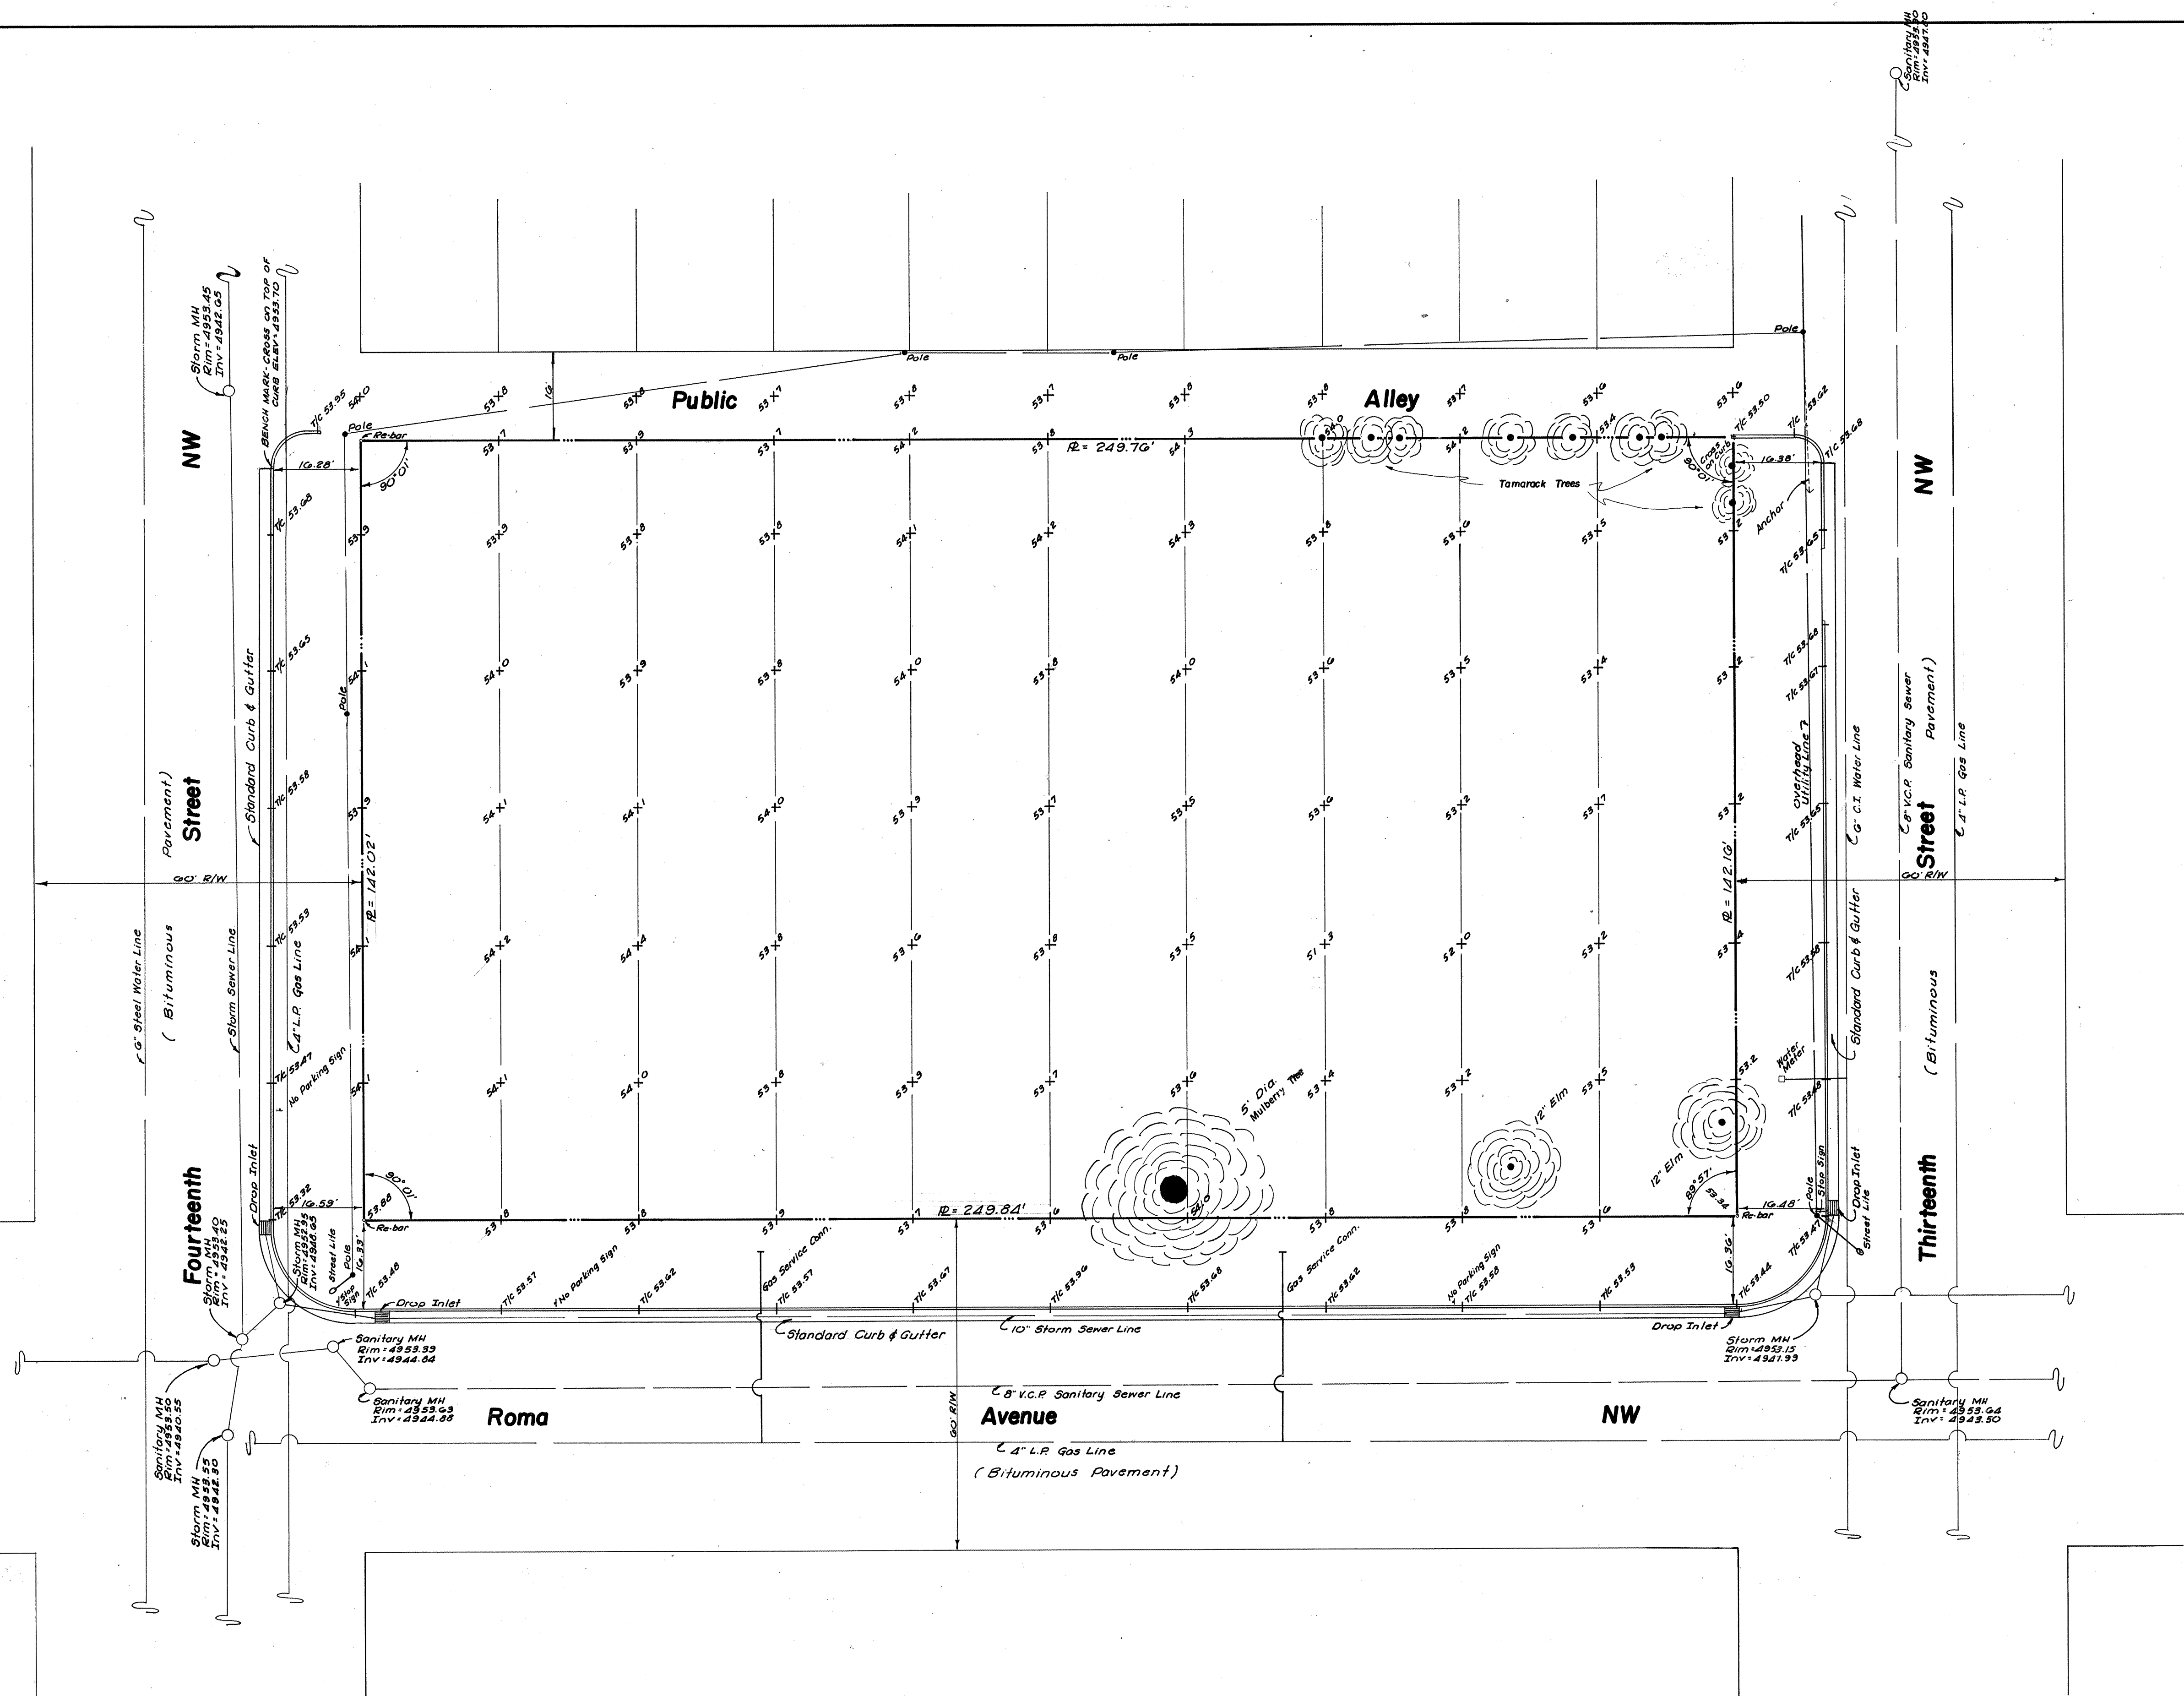


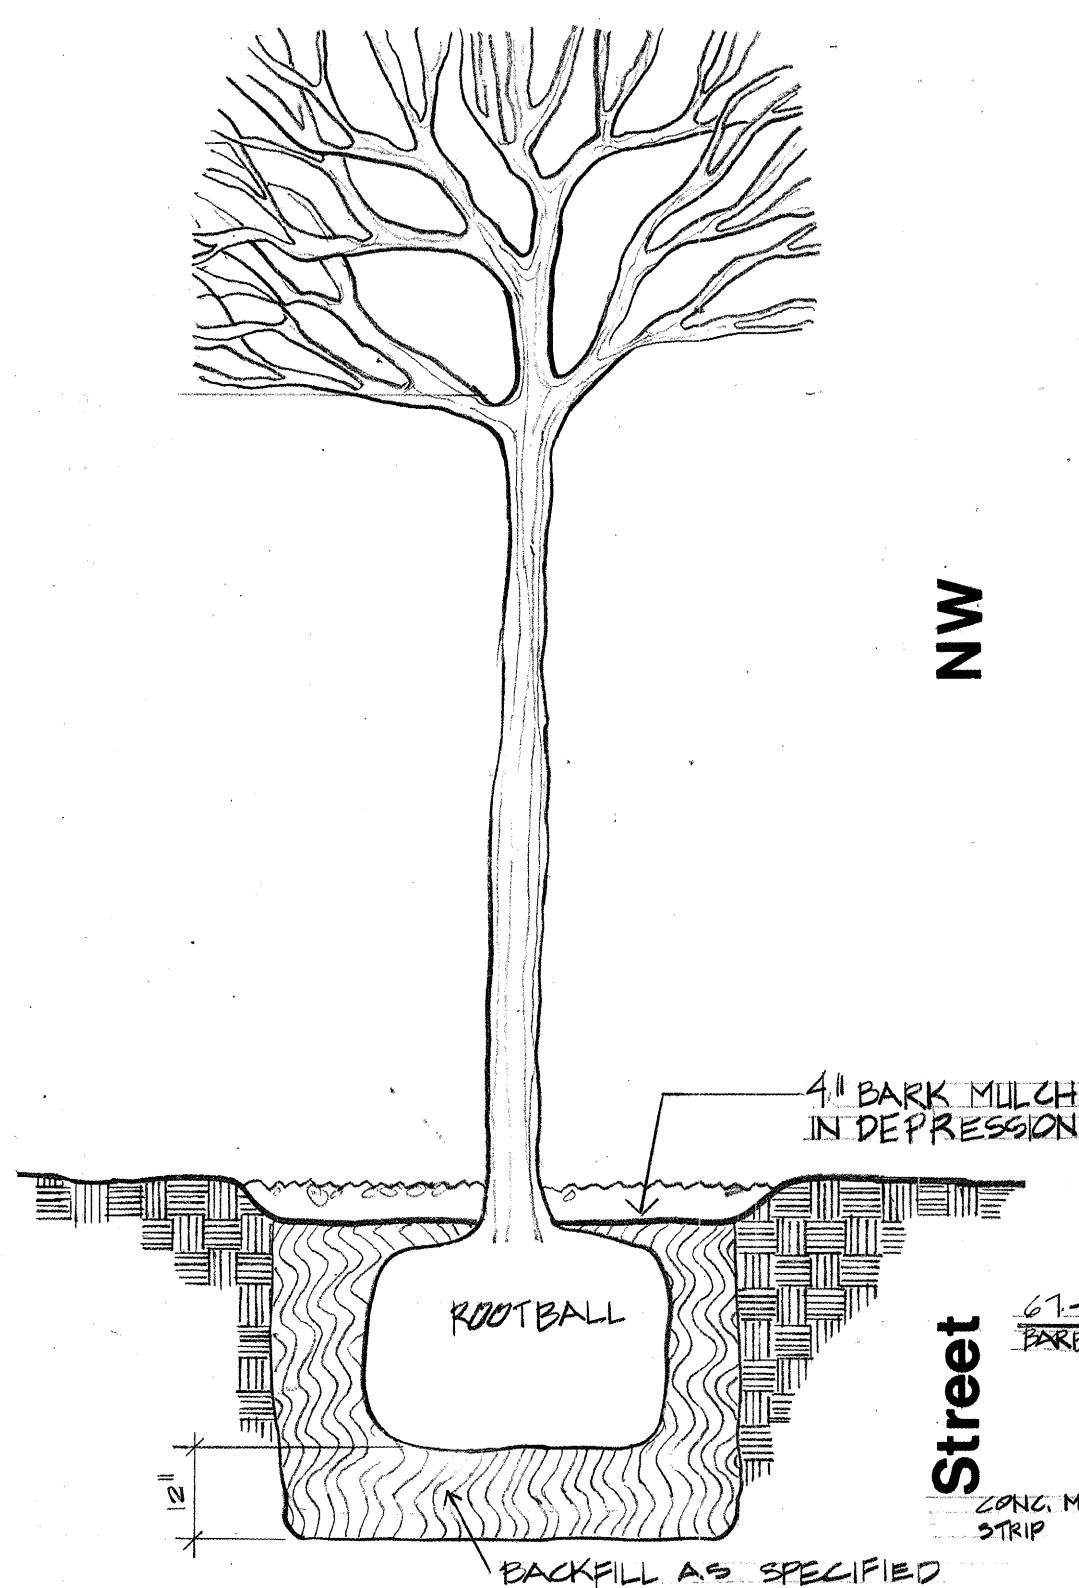

TREE PLANTING DETAIL
(TYPICAL IN NON-LAWN AREA) N.T.S.

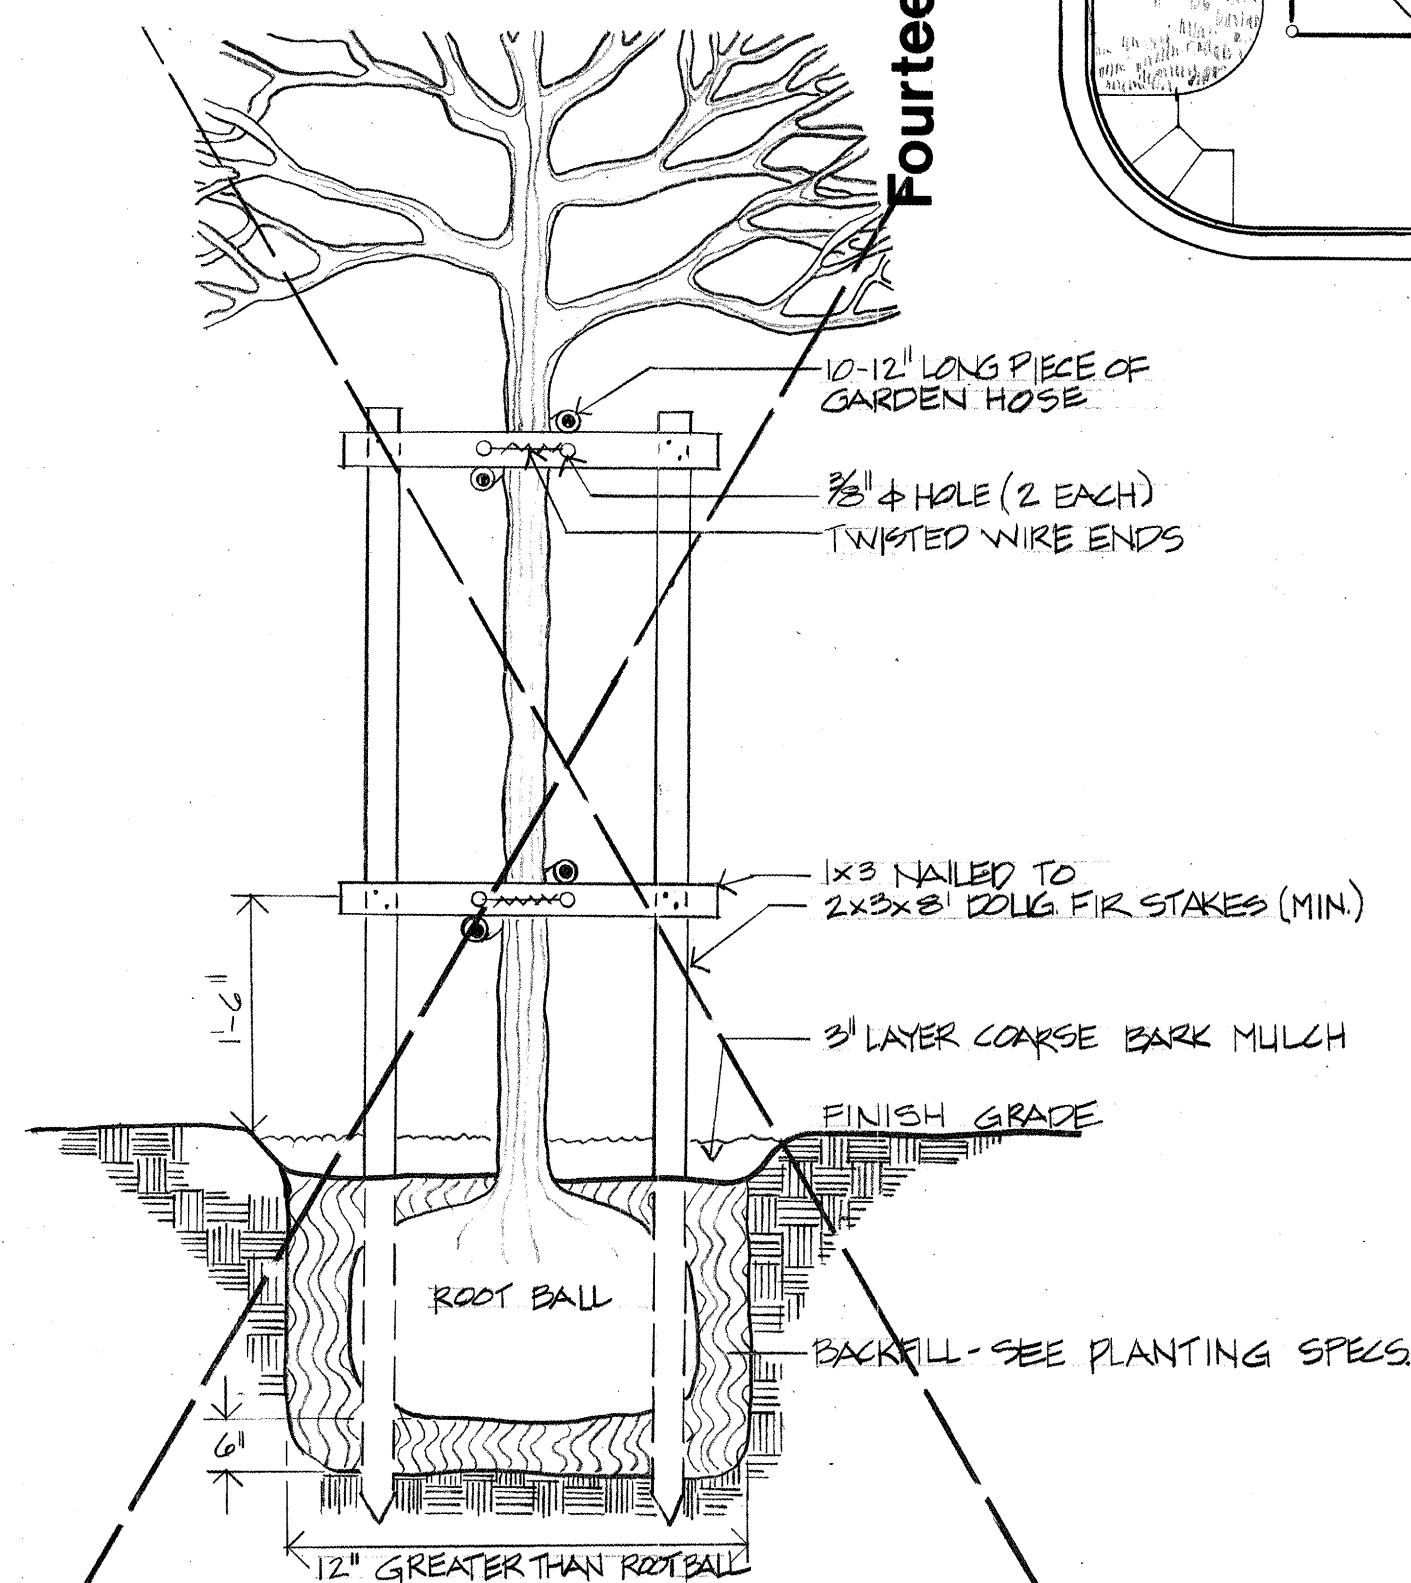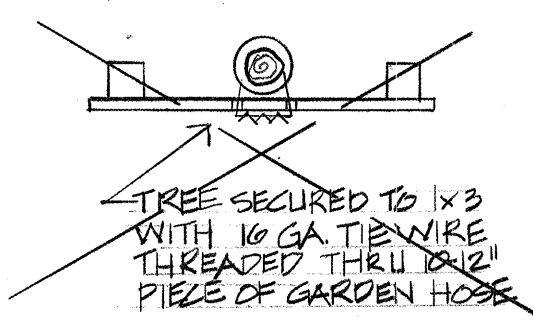

TREE STAKING AND PLANTING DETAIL
NO SCALE
(THIS DETAIL NOT REQUIRED THIS PROJECT)

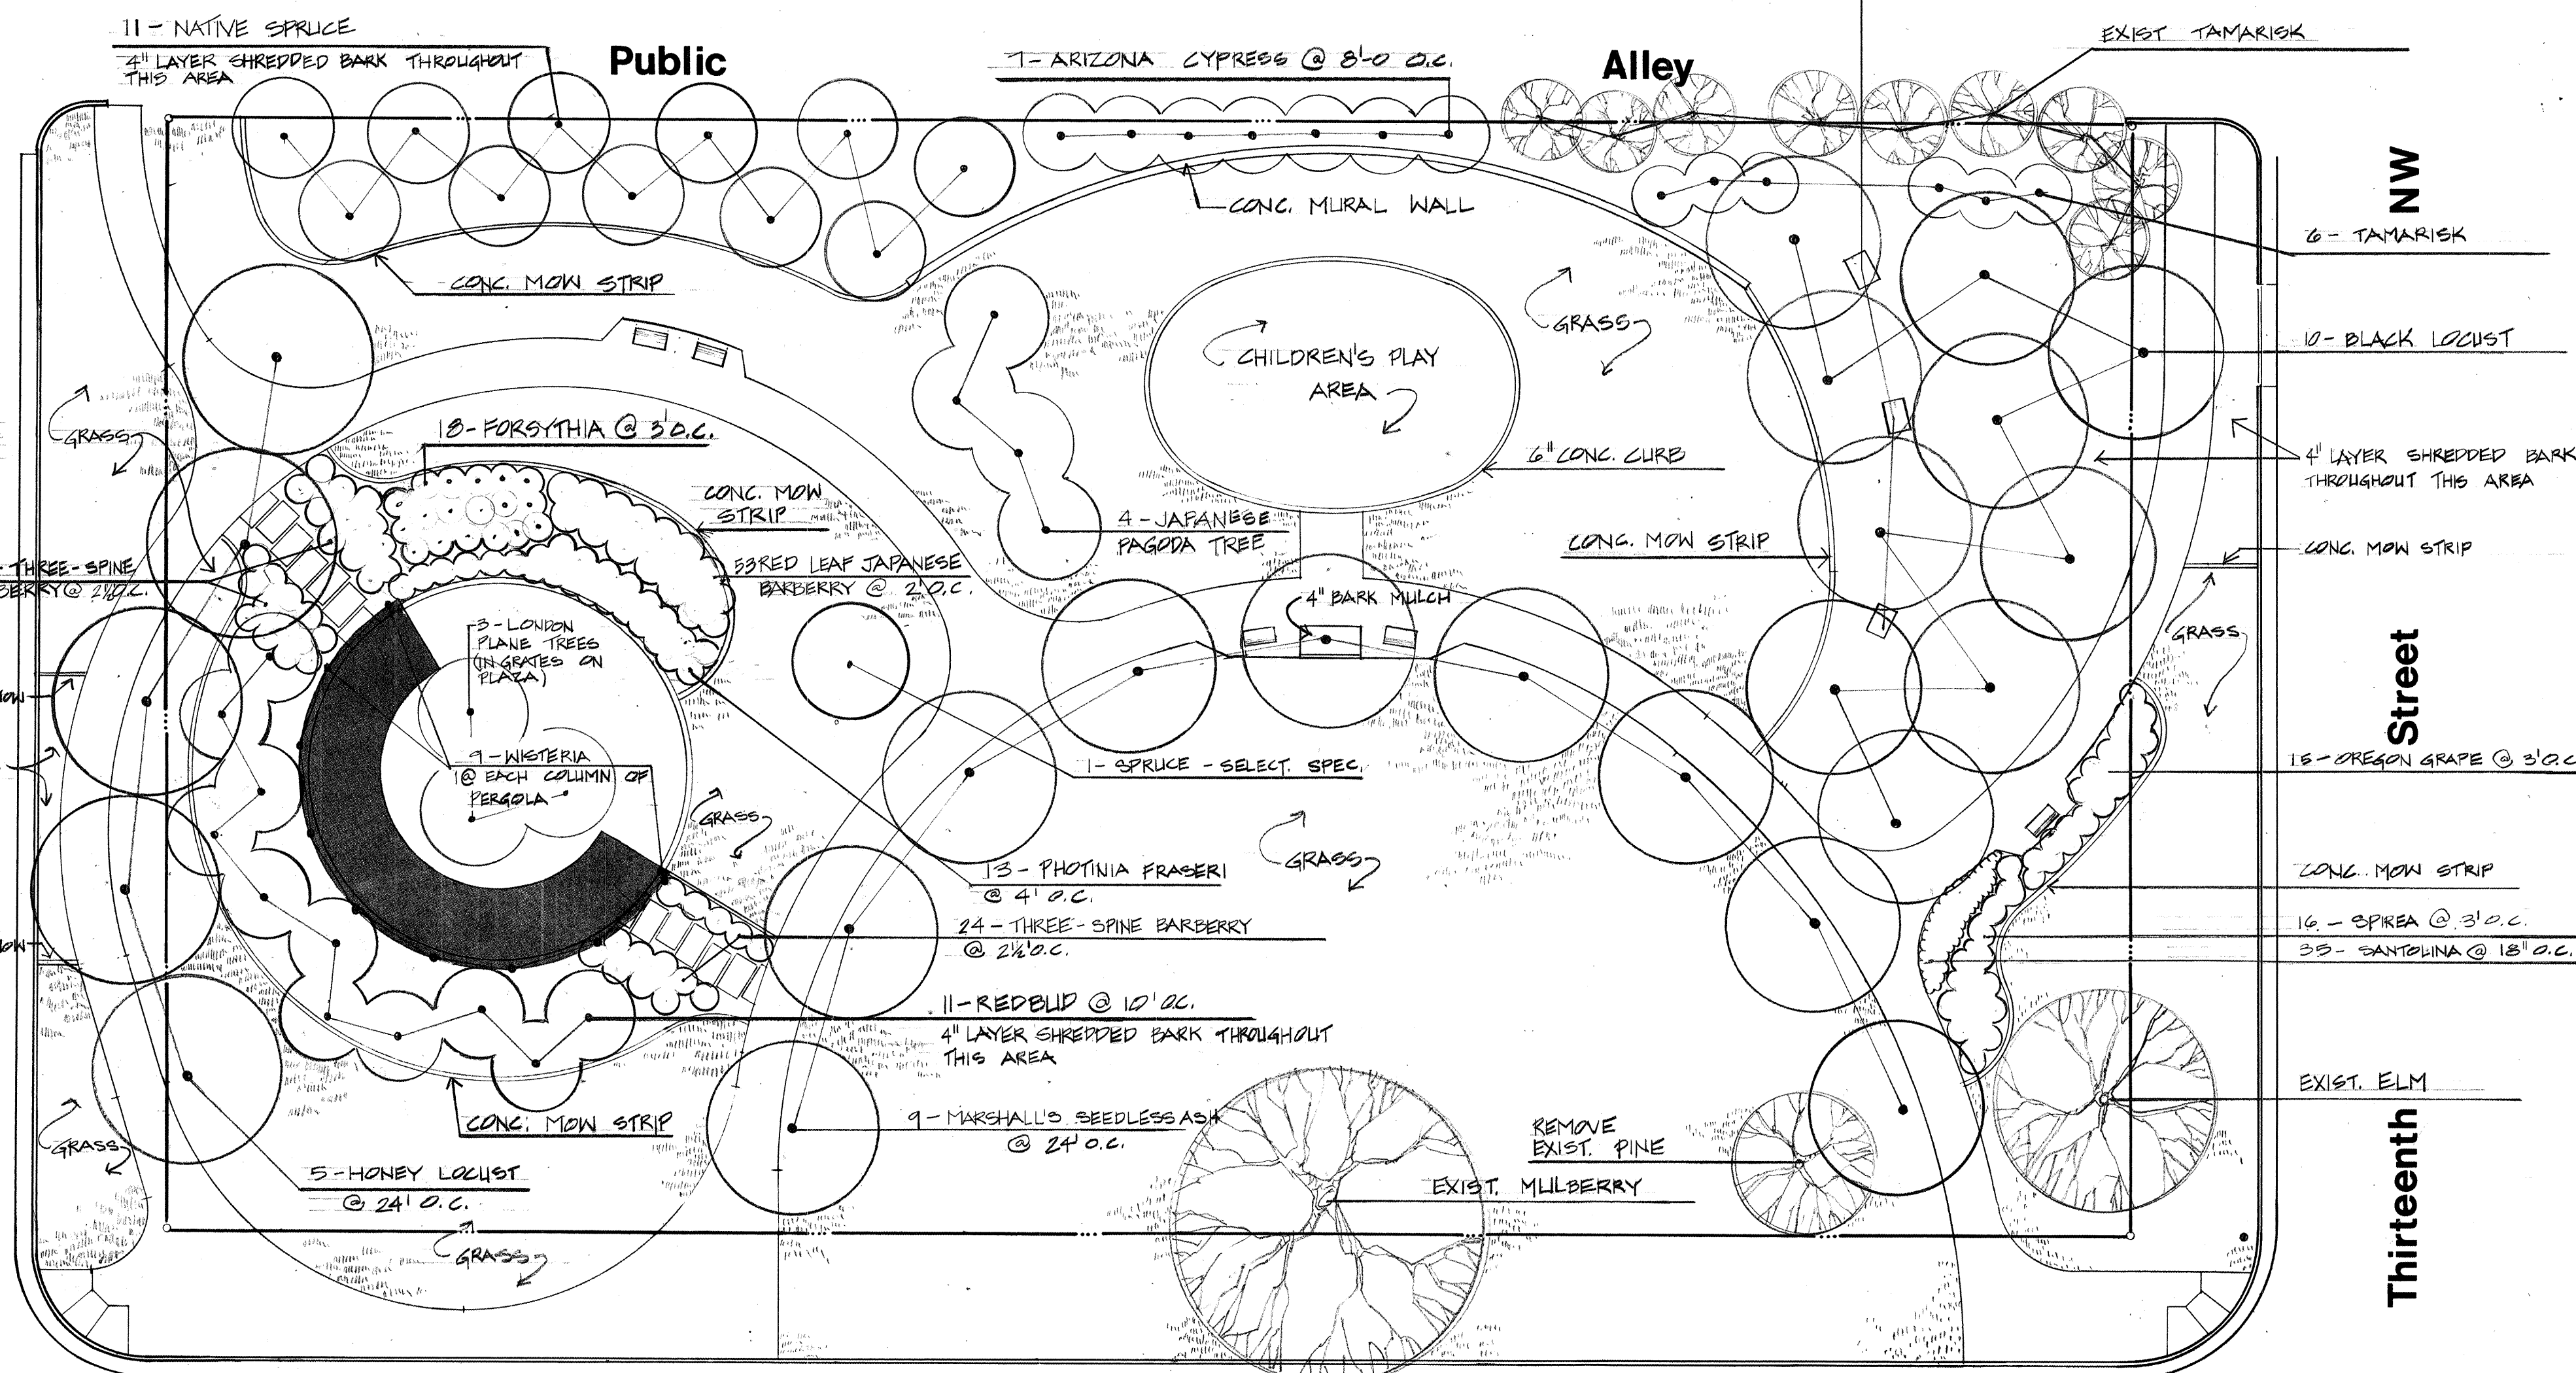

PLANT LIST

NO.	BOTANICAL NAME	COMMON NAME	SIZE	NOTES
33	SANTOLINA CHAMAECYPARISSUS	LAVENDER COTTON SANTOLINA	1 GAL.	18' O.C.
2	PLATANUS ACERIFOLIA	LONDON PLANE TREE	2 1/2' GAL.	1 PER TREE GRATE ON PLAZA
13	PHOTINIA FRASERI	PHOTINIA	15 GAL.	4' O.C.
16	SPIREA B. 'ANTHONY WATERER'	ANTHONY WATERER SPIREA	5 GAL.	3' O.C.
11	PICEA SP.	NATIVE SPRUCE	5' - 6'	B + B - FULL & HEALTHY
1	CUPRESSUS GLABRA	ARIZONA CYPRESS	15 GAL.	8' O.C.
6	TAMARIX PENTANDRA	TAMARISK (SALT CEDAR)	5 GAL.	5' - 6' HT.
10	ROBINIA PSEUDOACACIA	BLACK LOCUST	2 1/2' GAL.	SUBST. 3" MARSHALL SEEDLESS ASHOK
9	FRAXINUS P. 'MARSHALL'S SEEDLESS'	MARSHALL'S SEEDLESS ASH	3" CAL.	
4	SOPHORA JAPONICA	JAPANESE PAGODA TREE	2 1/2' GAL.	RADIANT PL. GRASS OK. AS SUBST.
91	BERBERIS TRIACANTHOPHORA	THREE-SPINE BARBERRY	5 GAL.	2 1/2' O.C.
33	BERBERIS T. 'ATROPURPUREA'	RED LEAF JAPANESE BARBERRY	5 GAL.	2' O.C.
15	MAHONIA AQUIFOLIUM	OREGON GRAPE	5 GAL.	3' O.C.
18	FORSYTHIA SUSPENS	FORSYTHIA - KIEPING	5 GAL./24" - 30"	3' O.C.
5	GLEDITSIA TRIACANTHOS 'SHADEMASTER'	HONEY LOCUST	3' CAL.	24' O.C.
1	PICEA SP. - SELECTED SPECIMEN	SPRUCE - SELECTED SPECIMEN	12' HT	TO BE APPROVED L.A.
11	CERCIS CANADENSIS	REDBLUD	2' CAL.	10' O.C.
9	WISTERIA FLORIBUNDA VAR.	JAPANESE WISTERIA	15 GAL.	VARIETY TO BE APPROVED BY L.A.

GRASS SEED MIXTURE:

VARIETY	GERM	PURITY	MIXTURE
MERON BLUEGRASS	82%	94%	2 LBS / 1000 SQ. FT.
PARON BLUEGRASS	82%	94%	2 LBS / 1000 SQ. FT.
MANHATTAN PERENNIAL RYE	90%	98%	2 LBS / 1000 SQ. FT.
TOTAL RATE: 6 LBS / 1000 SQ. FT.			

FOR INFORMATION ONLY


planting plan
mary fox park
albuquerque, nm

REVISIONS

craig
campbell
associates

landscape architects
site planners

ALBUQUERQUE · SANTA FE

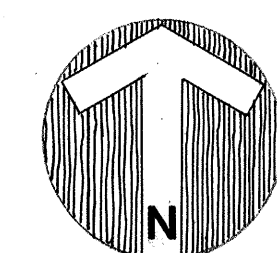

SCALE: 1/8" = 1'-0"



DATE: SEPT '78

DRAWN: F.O.


CHECKED: C.C.

SHEET NUMBER

5

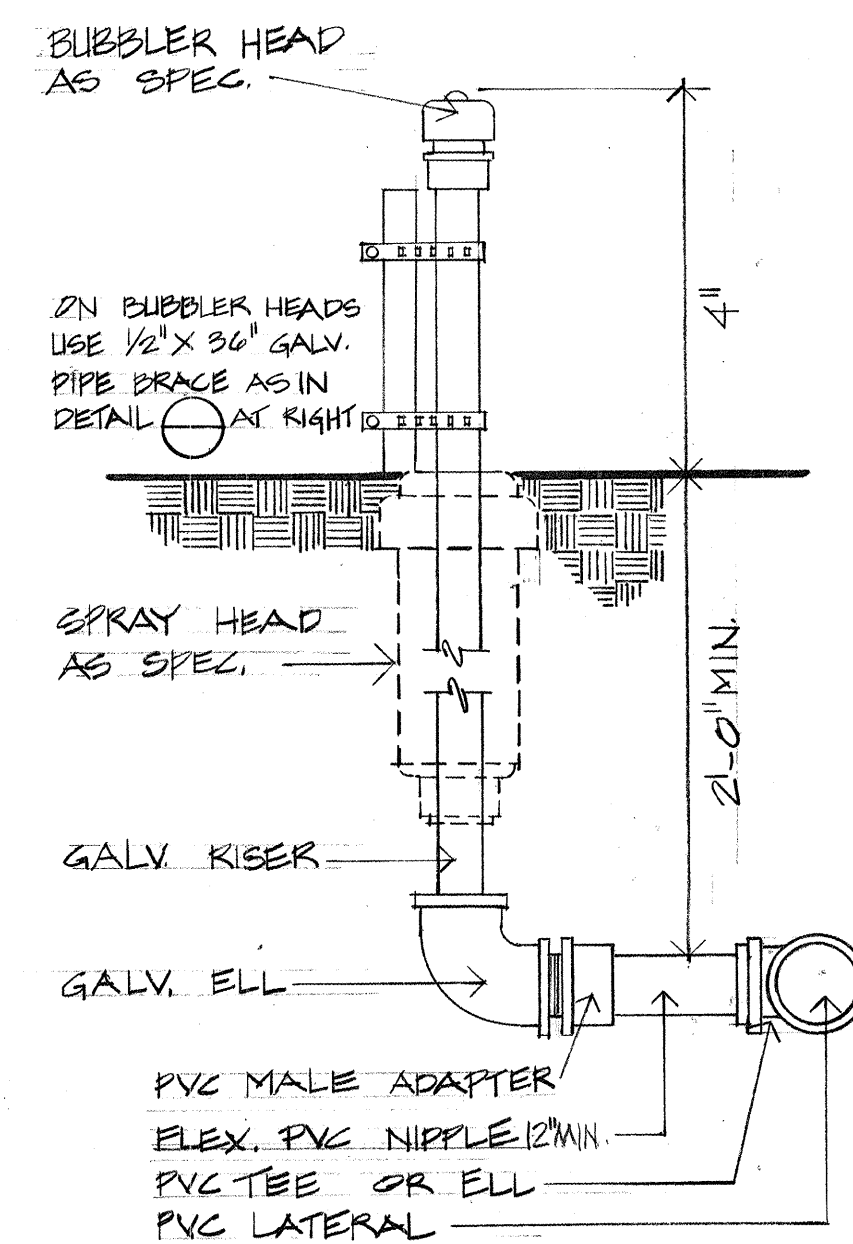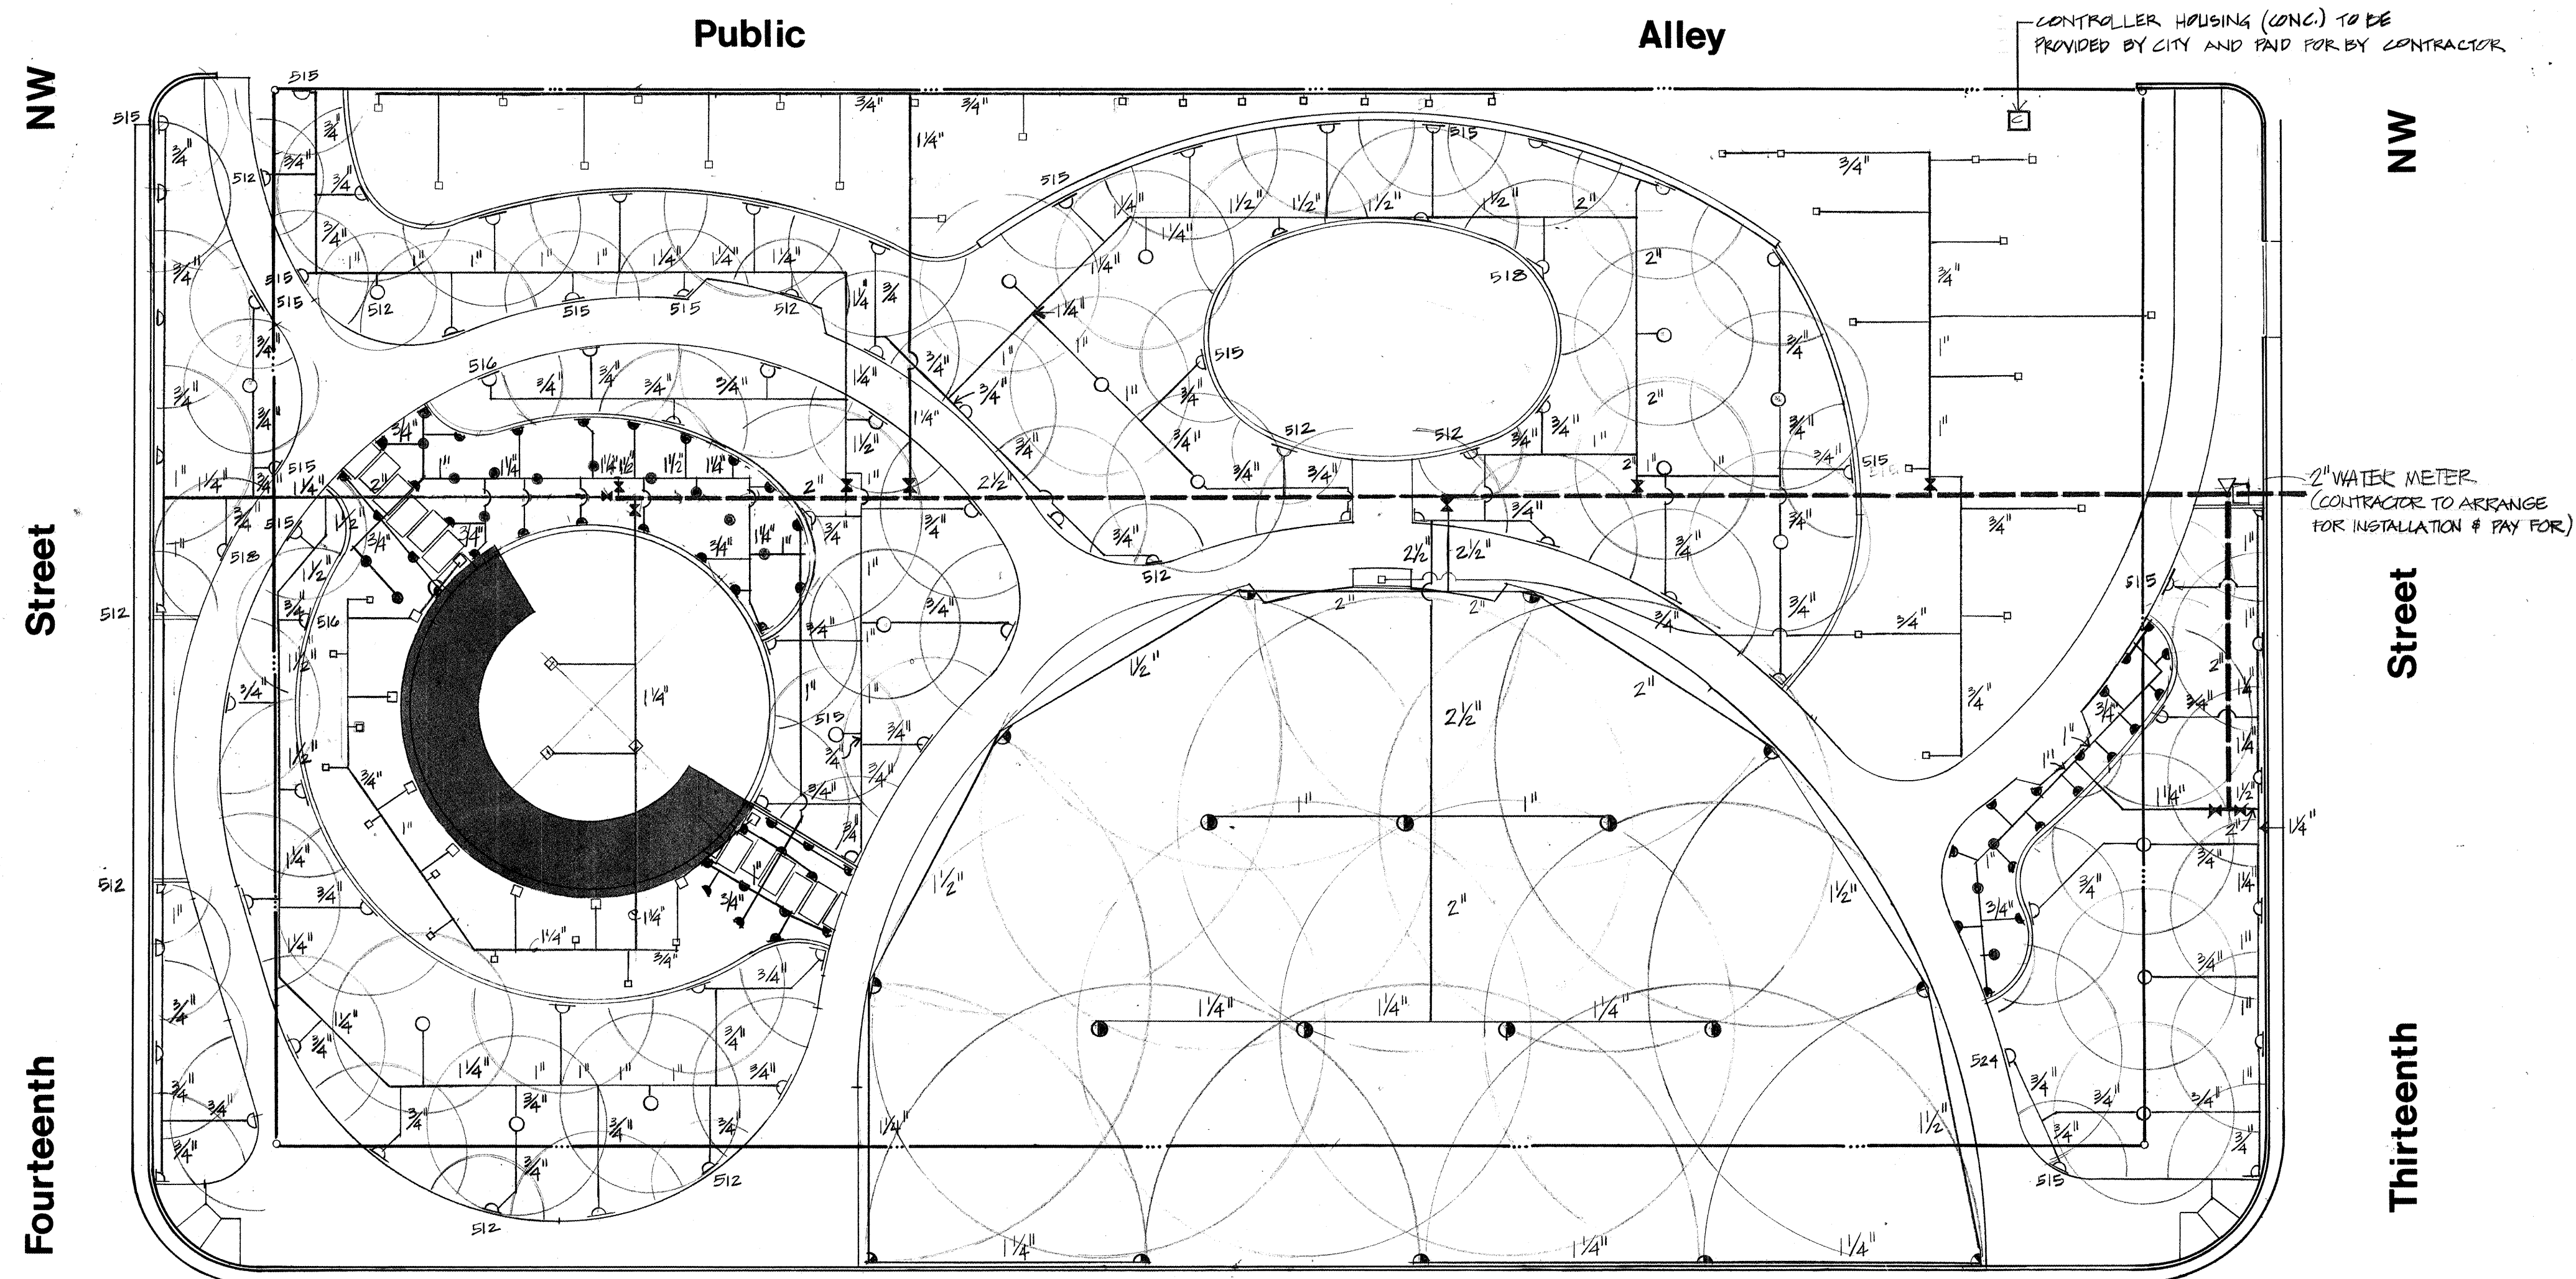

1
RISER DETAIL
6

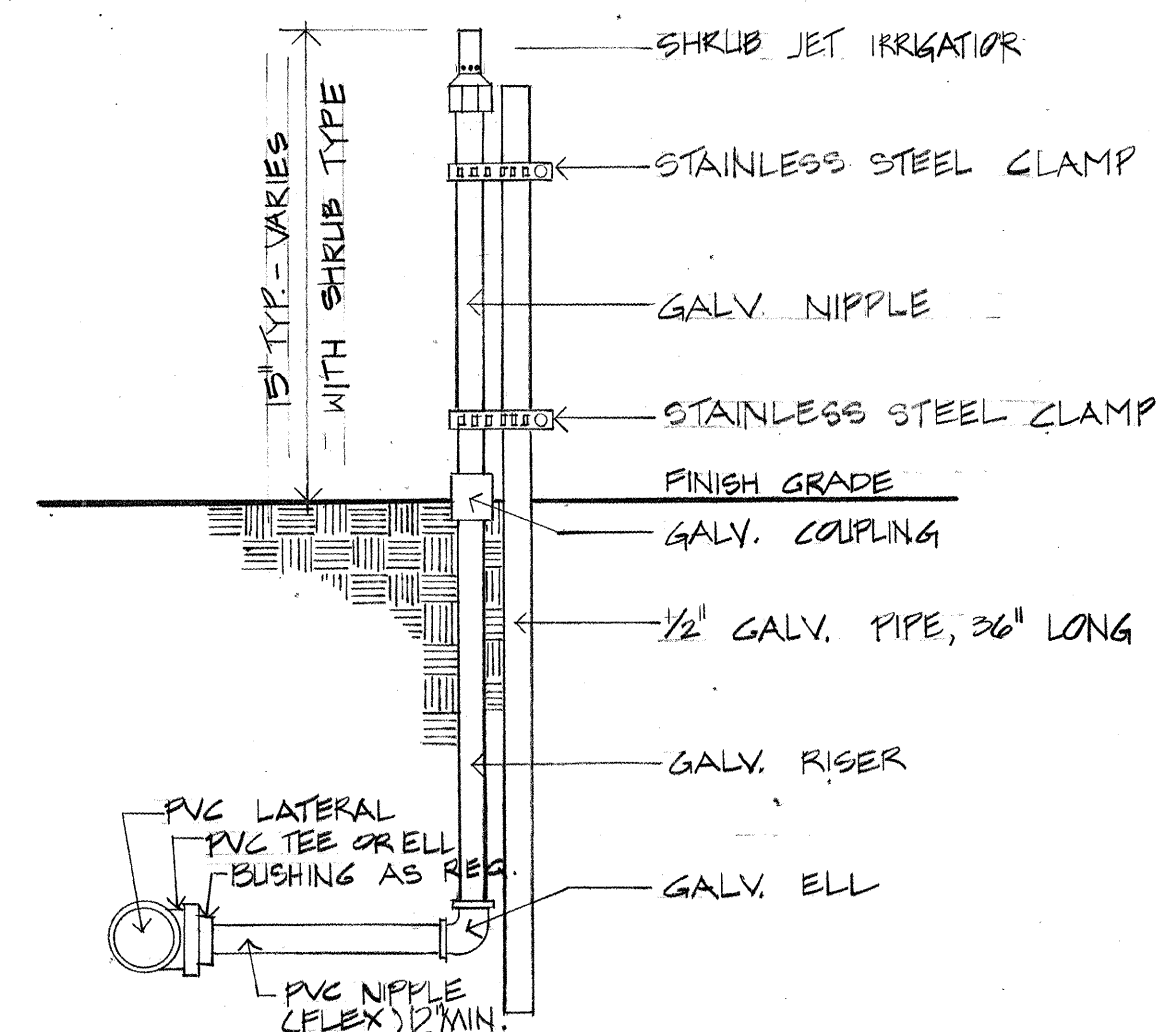

2
SHRUB RISER DETAIL
6


LEGEND

- △ △ △ WEATHER-MATIC SUPER-POP SPRAY HEAD - BRONZE BODY W/ 520 NOZZLE UNLESS OTHERWISE NOTED.
- △ △ △ " " 1/4" F.H.Q NOZZLE ON 73 ADAPTOR
- △ △ △ " " BUBBLER HEAD #103
- △ △ △ RAN-O-MAT ROTARY POP-UP SPRINKLER W/ RUBBER COVER 1P, 9H, 9Q
- ✕ WEATHER-MATIC ELECTRO-VAL 8000 SERIES REMOTE CONTROL VALVE
- " " SSR 10 CONTROLLER - TO BE PLACED IN CONCRETE HOUSING PROVIDED BY CITY.
- LATERALS - CLASS 200 PVC
- MAIN LINE - (NON-PRESSURE) SCHEDULE 40 PVC
- FIBCO MOD. 805 - DOUBLE CHECK BACKFLOW PREVENTER OR APPROVED EQUAL - PROVIDE BASS AND HAYES OR EQ. GALV. COR. 3/8" Ø SHELL W/C.I. LOCKING COVER
- ▽ WEATHER-MATIC - I ELECTRO-VAL MASTER VALVE 8034-B FAK 2 1/2"

irrigation plan
mary fox park
albuquerque, nm


REVISIONS

craig
campbell
associates

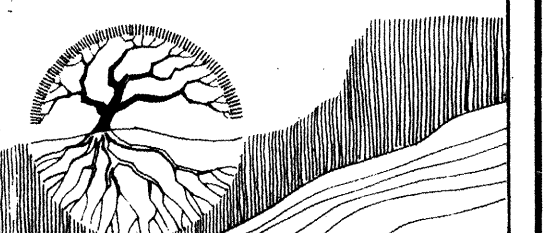

landscape architects
site planners

ALBUQUERQUE · SANTA FE

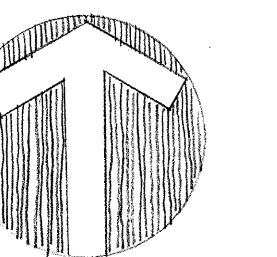

SCALE: 1/16" = 1'-0"

DATE: SEPT. 78

DRAWN: C.C.


CHECKED: M.W.

SHEET NUMBER


6

FIXTURE SCHEDULE


TYPE	DESCRIPTION	LAMPS	MOUNTING
'A'	KENALL #1140 HO (-20")/2 (9000)	1140 T12 CW HO	SURFACE, SEE DETAIL (3)
'B'	PRESCOLITE #93047/ LEXAN	115W MV DLK. WH	RECESSED
'C'	STERNER #WT-S-2A-AV-10-N-400H-120-C/RDS-44-D-C-N (301)	1400W MH PHOSPHOR	POLE, SEE DETAIL (1)
'D'	MOLDCAST #3220 ASYMMETRIC/DURANODIC DARK BRONZE / BT/RA	1250 W MH PHOSPHOR	POLE, SEE DETAIL (4)

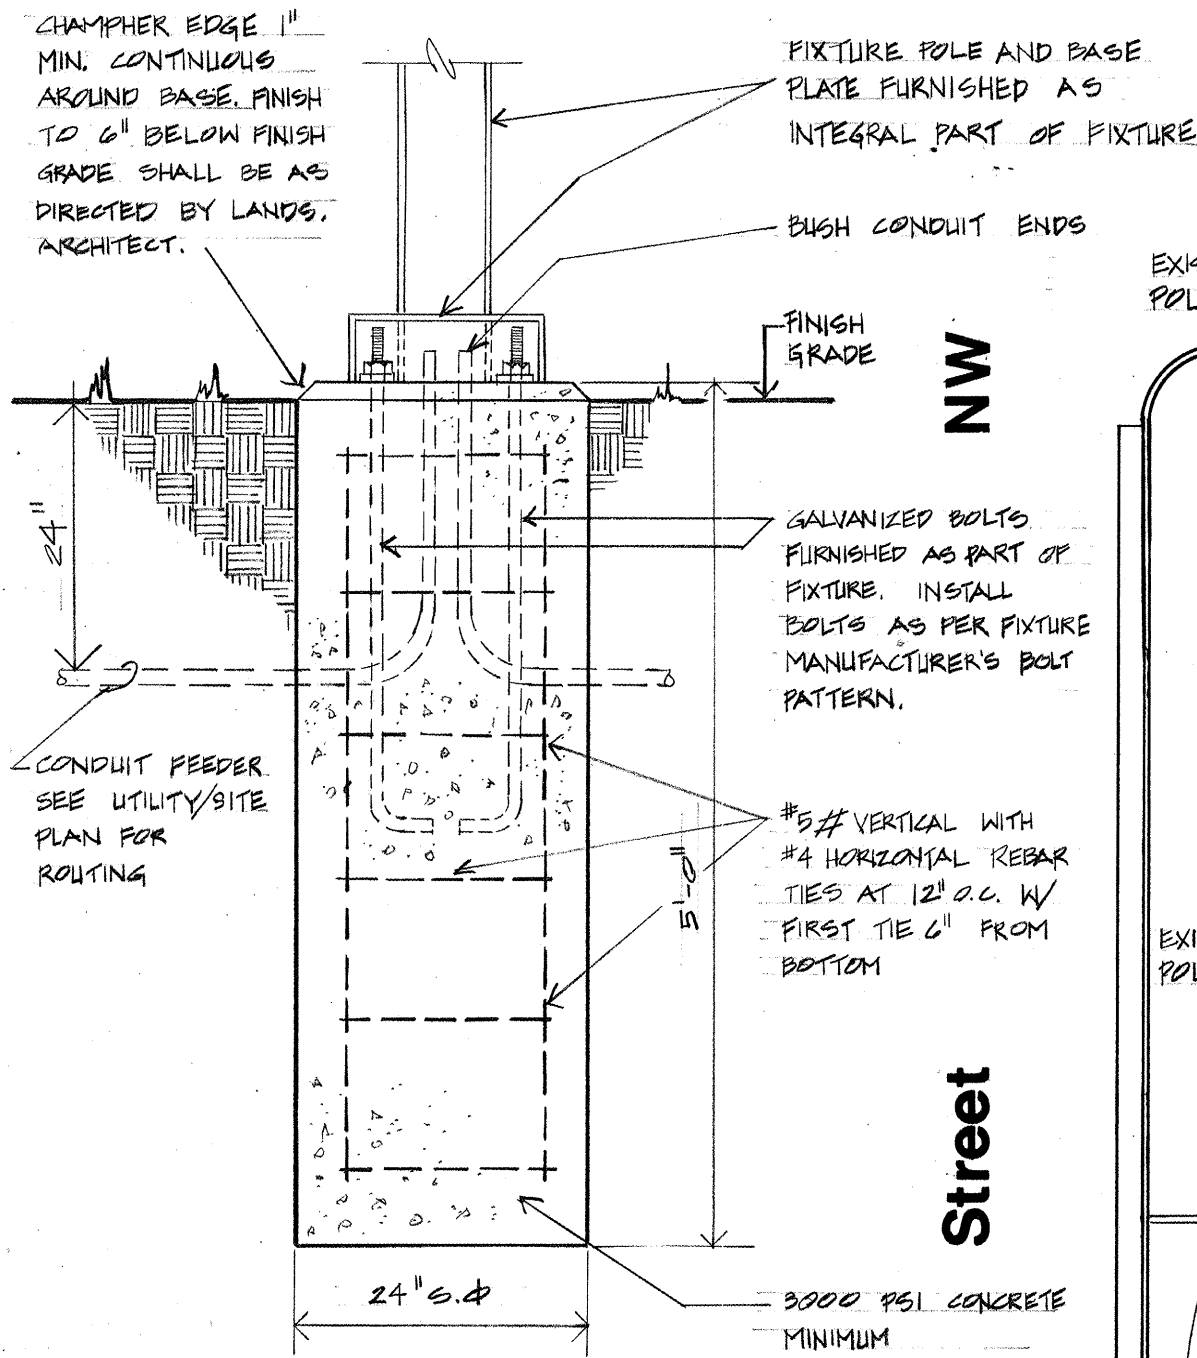

FIXTURE TYPES 'C' & 'D' MOUNTING DETAIL
 NO SCALE

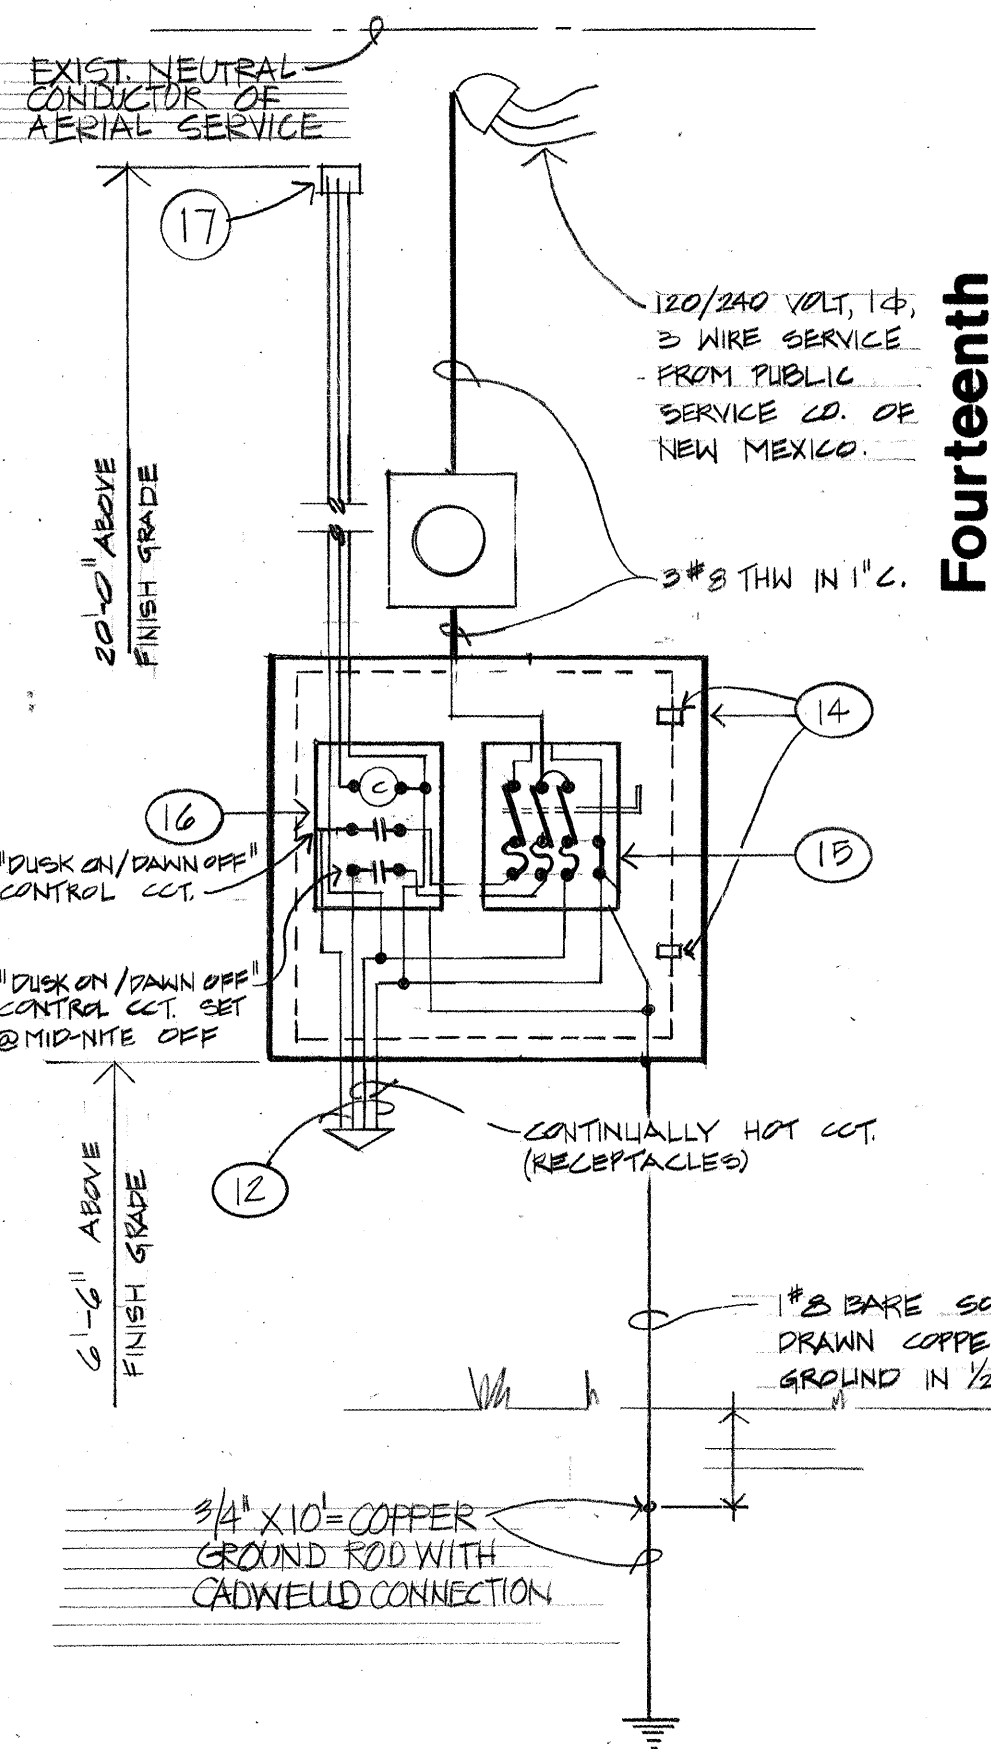


POWER RISER DIAGRAM/ELEVATION
 NO SCALE

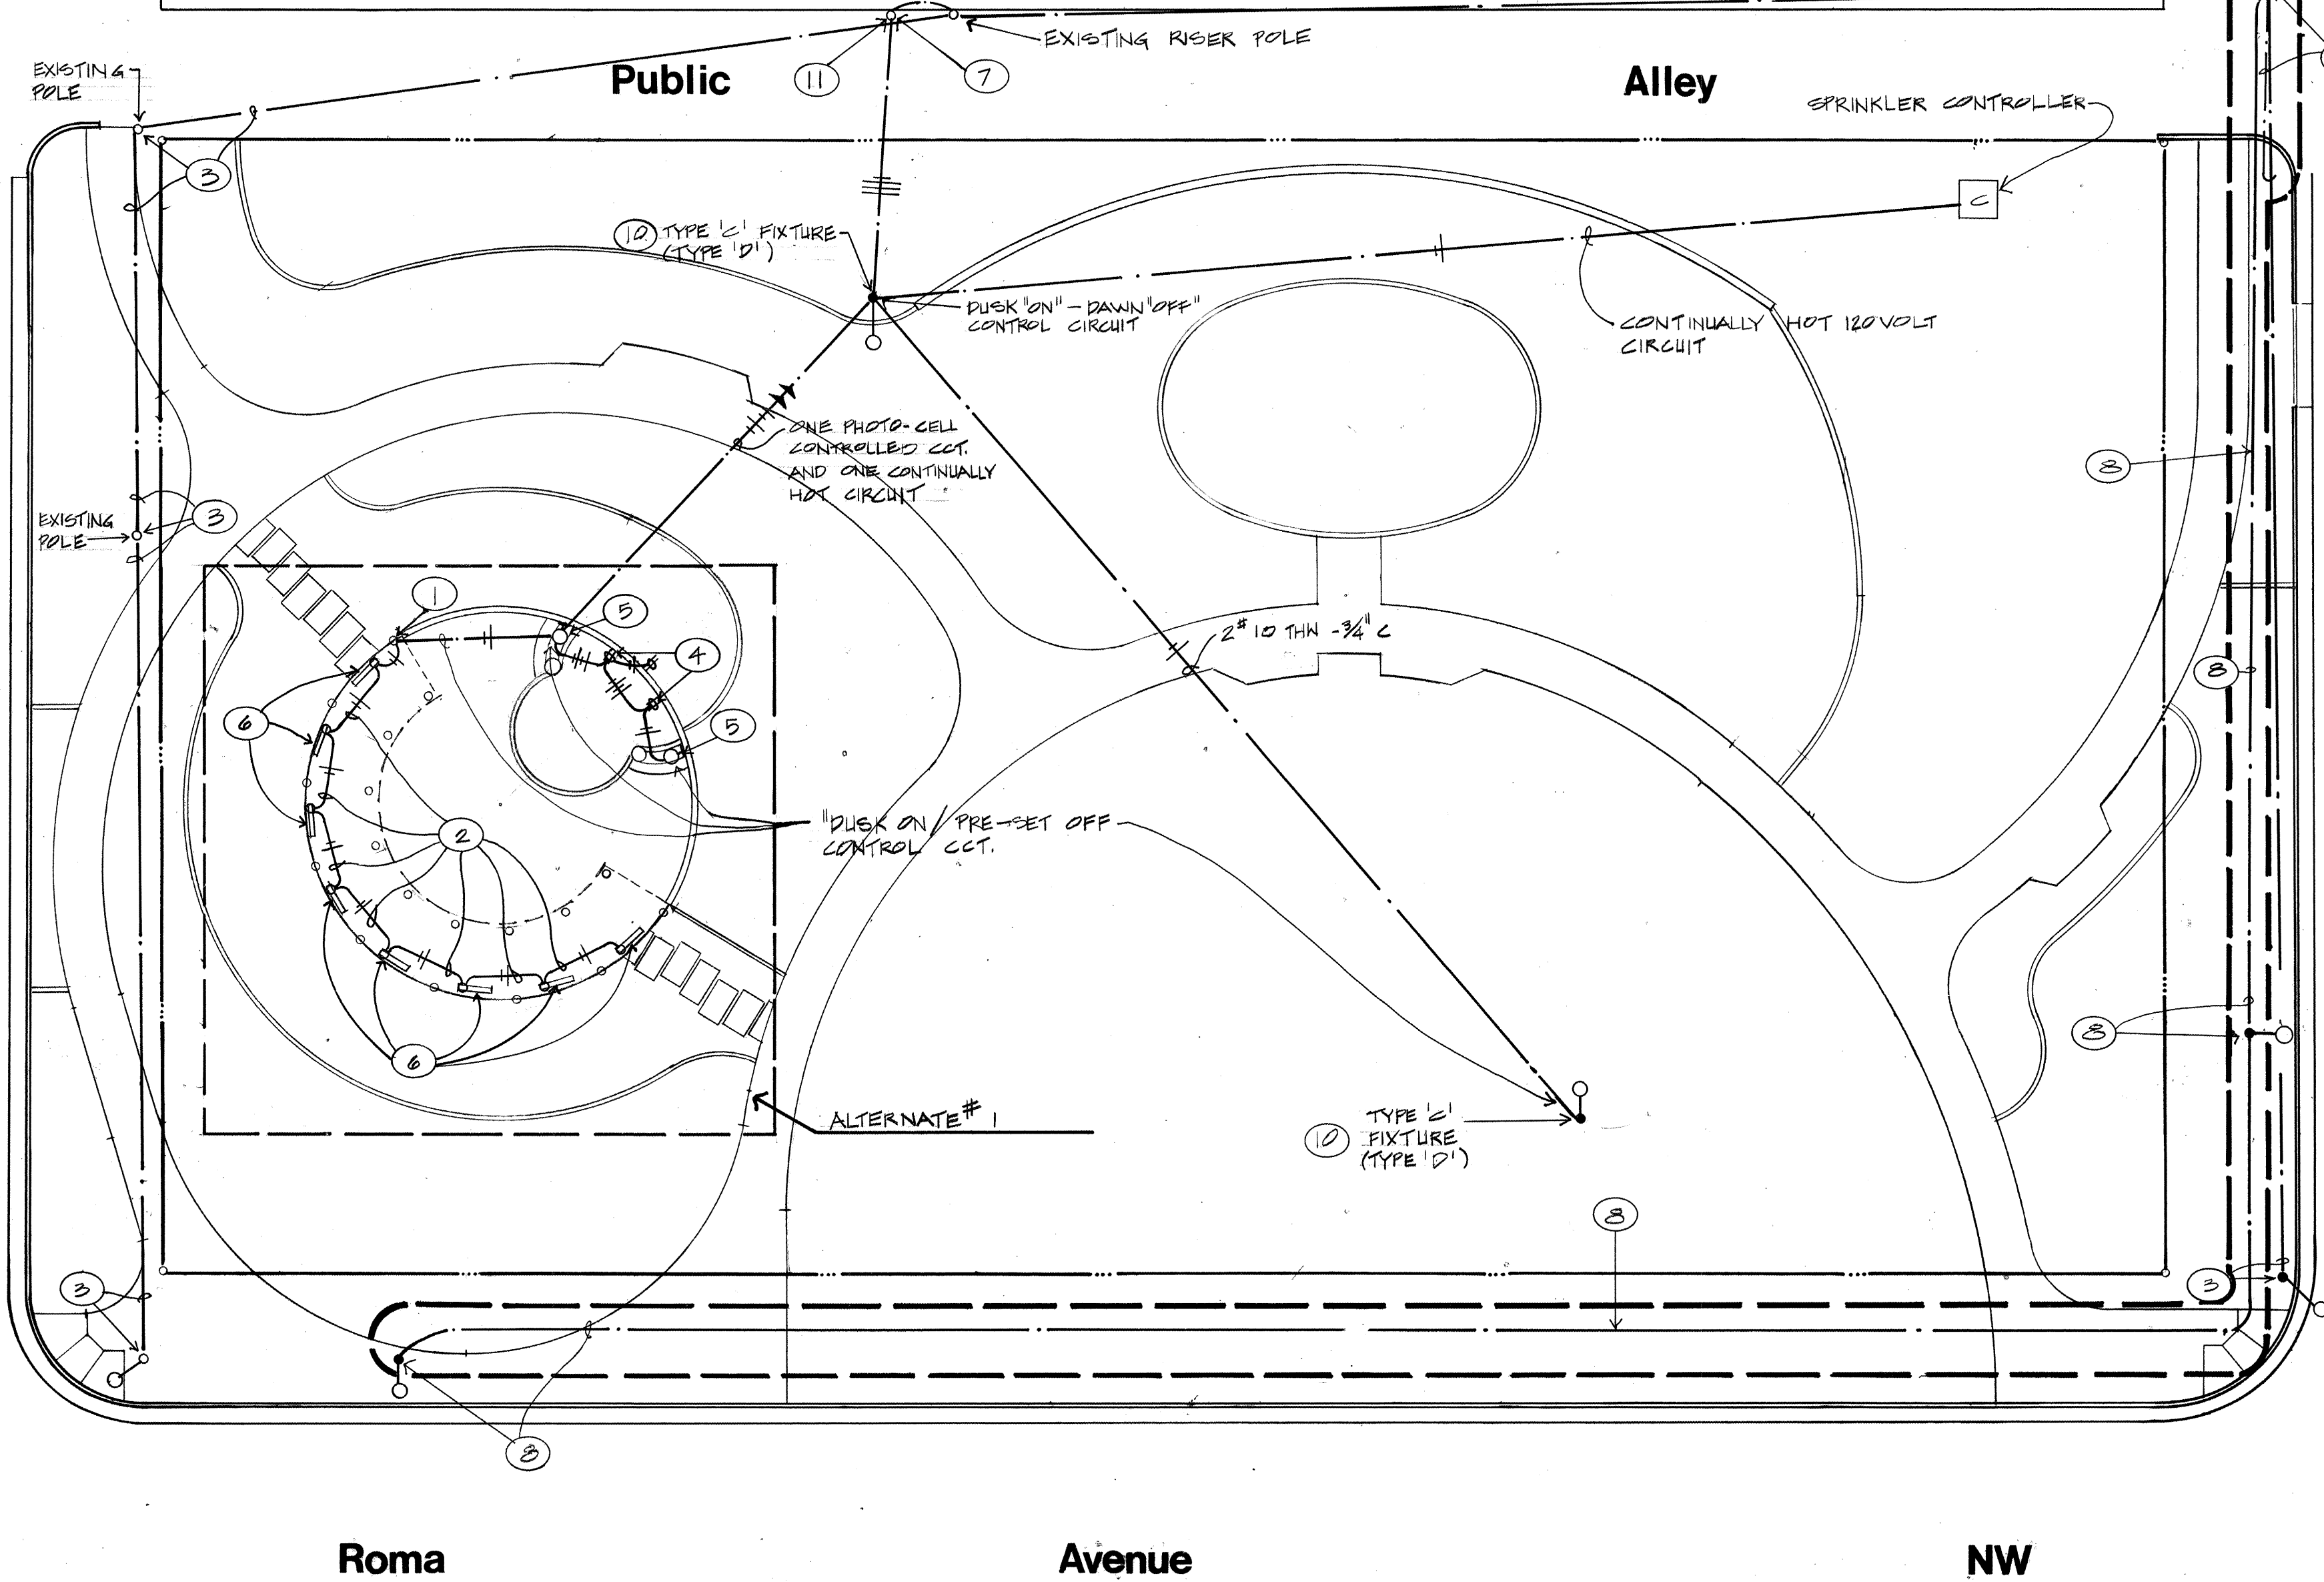

KEYED NOTES

- Extend feeder up in concrete column to wood structure above and then within structure per detail this sheet.
- Rigid steel conduit (painted) surface mounted to horizontal 4 x 6 wood structural member. Each feeder between fixtures shall be strapped at a minimum of 3 places. Conduit and associated support devices shall be painted in a color as selected by the Landscape Architect.
- This Contractor shall be responsible for coordination with the City of Albuquerque/Public Service Company of New Mexico to have the existing pole mounted fixture removed. The removal shall include existing overhead power lines back to alley and Thirteenth Street for fixture at Thirteenth and Roma, and the aerial line plus two support poles back to the existing pole at the alley. (Existing pole serving new lighting within the Park)
- Furnish Pass and Seymour #4501 ground fault circuit interrupter duplex receptacle and install in a flush mounted weatherproof enclosure with locking cover (both locks keyed alike) P & S #1591-WP. Cover shall be painted in color as selected by the Landscape Architect and shall be installed 24\"/>
- Type "B" fixture, install bottom of fixture at 12\"/>
- Type "A" fixtures shall be installed centered horizontally between respective concrete columns and centered vertically on 4 x 6 wood member. Fixture shall be secured to wood structure with a minimum of (12) 3/8\"/>
- 4 #10 THW in 1\"/>
- New street lighting (two fixtures) along with underground feeder shall be furnished and installed by Public Service Company of New Mexico. The new street lighting system is indicated within the area of dashed lines along Roma and Thirteenth. (N.M.C.)
- Install conduit riser along with weatherhead as per the requirements of Public Service Company of N.M.
- This Contractor shall furnish Type 'C' fixture as part of Base Bid and add or deduct figure for substituting Type 'D' fixtures in Alternate No. 4 of Bid Proposal.
- This Contractor shall furnish a 25' minimum (above grade) wood pole and install at location indicated, for slack conductor connection from Public Service Company. Install cabinet, meter, and weatherhead, as indicated in power riser diagram, on pole.
- 4 #10 THW in 1\"/>
- Furnish and install metering enclosure on pole per the requirements of Public Service Co. of New Mexico.
- Furnish a Nema 4 or 5 cabinet with plywood backboard and double hasp latch. Cabinet shall be furnished in size as required to accommodate equipment indicated and provide ample wiring space. This Contractor shall furnish (2) "Master" locks which are keyed alike.
- 30 amp, 3 pole + SN, 250 volt, Nema 3R fusible disconnect switch. Fuse each pole of switch with 20 amp Buss Fusetrons.
- Tork # 902LE lighting control center.
- Photo-electrical control with flush mounted matching receptacle, American Electric No. 8090-2.

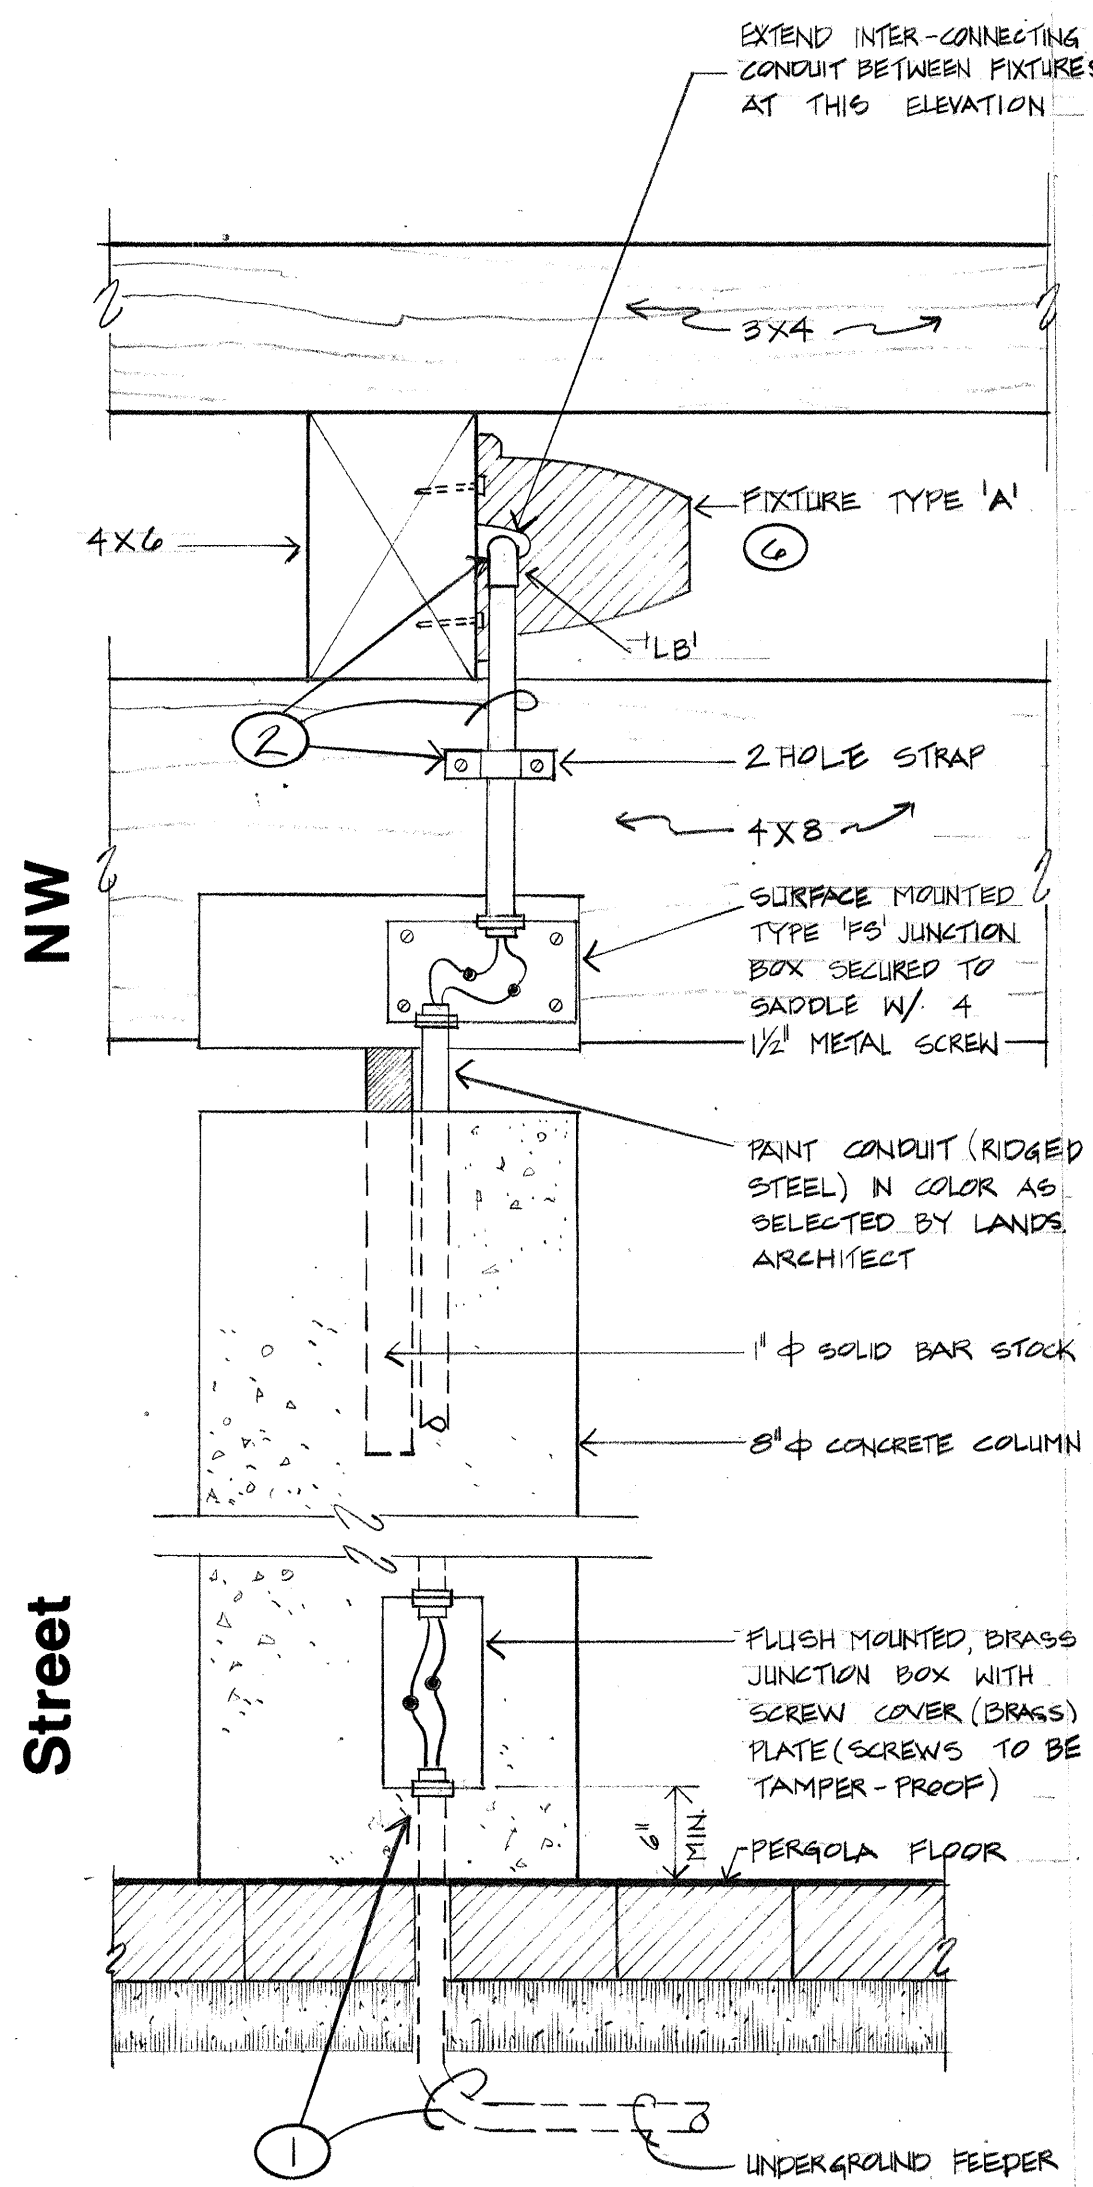

TYPE 'A' FIXTURE MOUNTING DETAIL
 NO SCALE

NOTE:
 ALL EXPOSED CONDUIT AND BOXES SHALL BE PAINTED IN COLOR AS SELECTED BY ARCHITECT.


DESIGN BY: TIERRA DEL SOL ENGINEERING
 1704 NOON NE - ALBUQUERQUE, N.M. 87112
 TEL: 293-9250

electrical plan
 mary fox park
 albuquerque, nm

REVISIONS

craig
 campbell
 associates
 landscape architects
 site planners

ALBUQUERQUE · SANTA FE

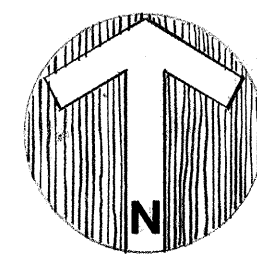

SCALE: 1/16" = 1'-0"






DATE: SEPT '18

DRAWN: P.O.


CHECKED: C.C. / H.P.

SHEET NUMBER




7

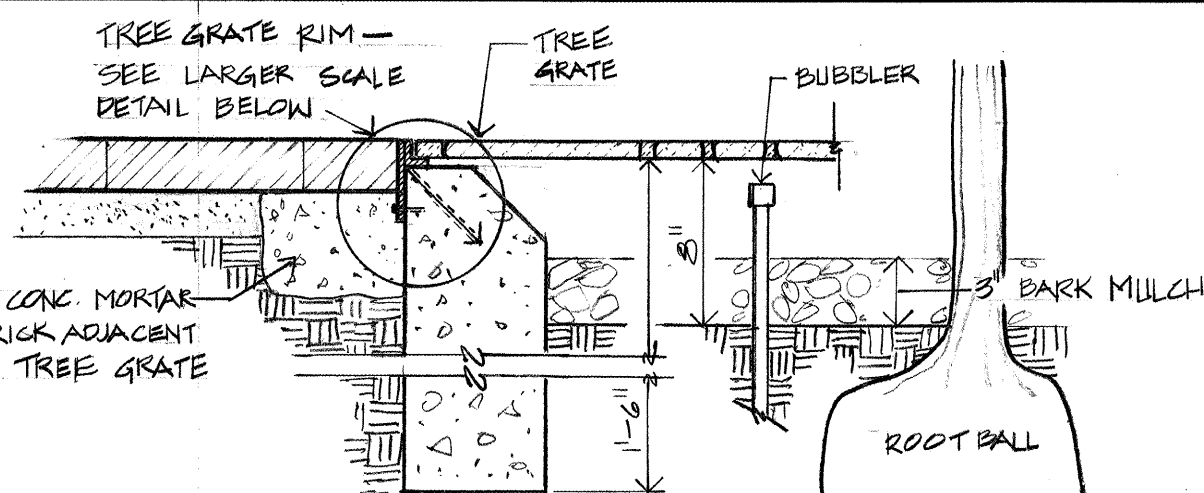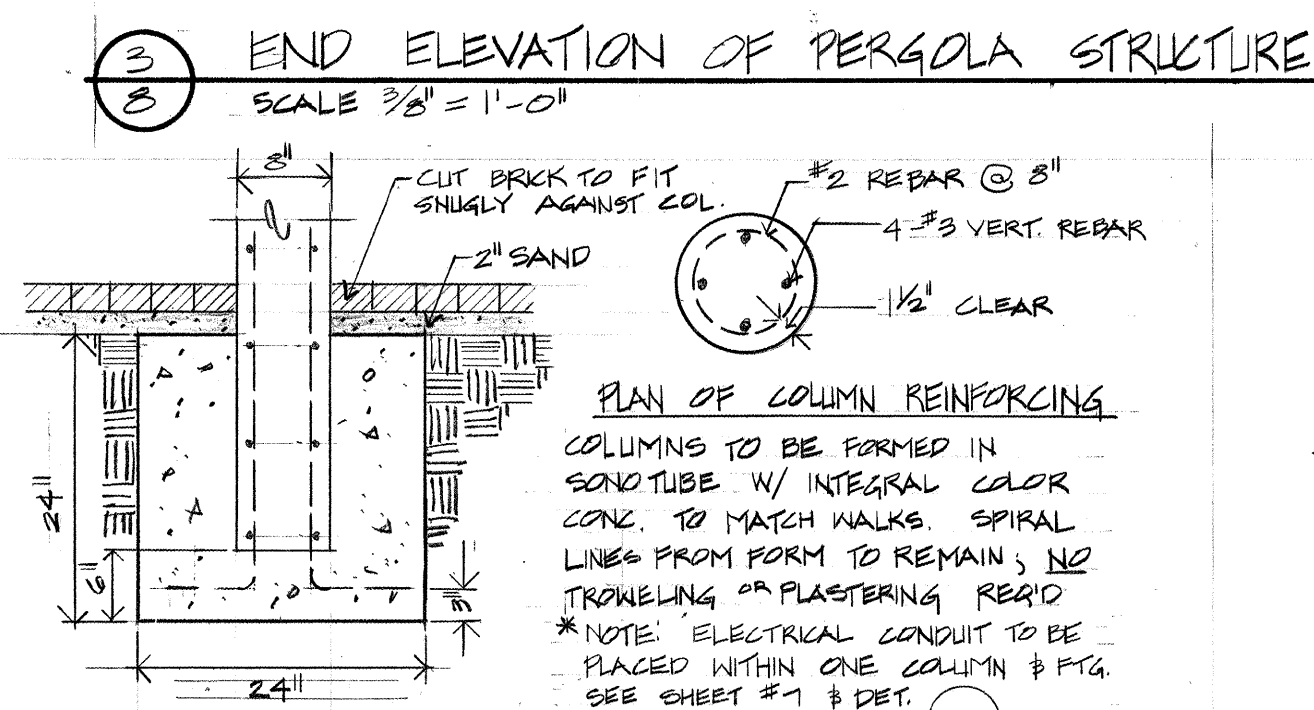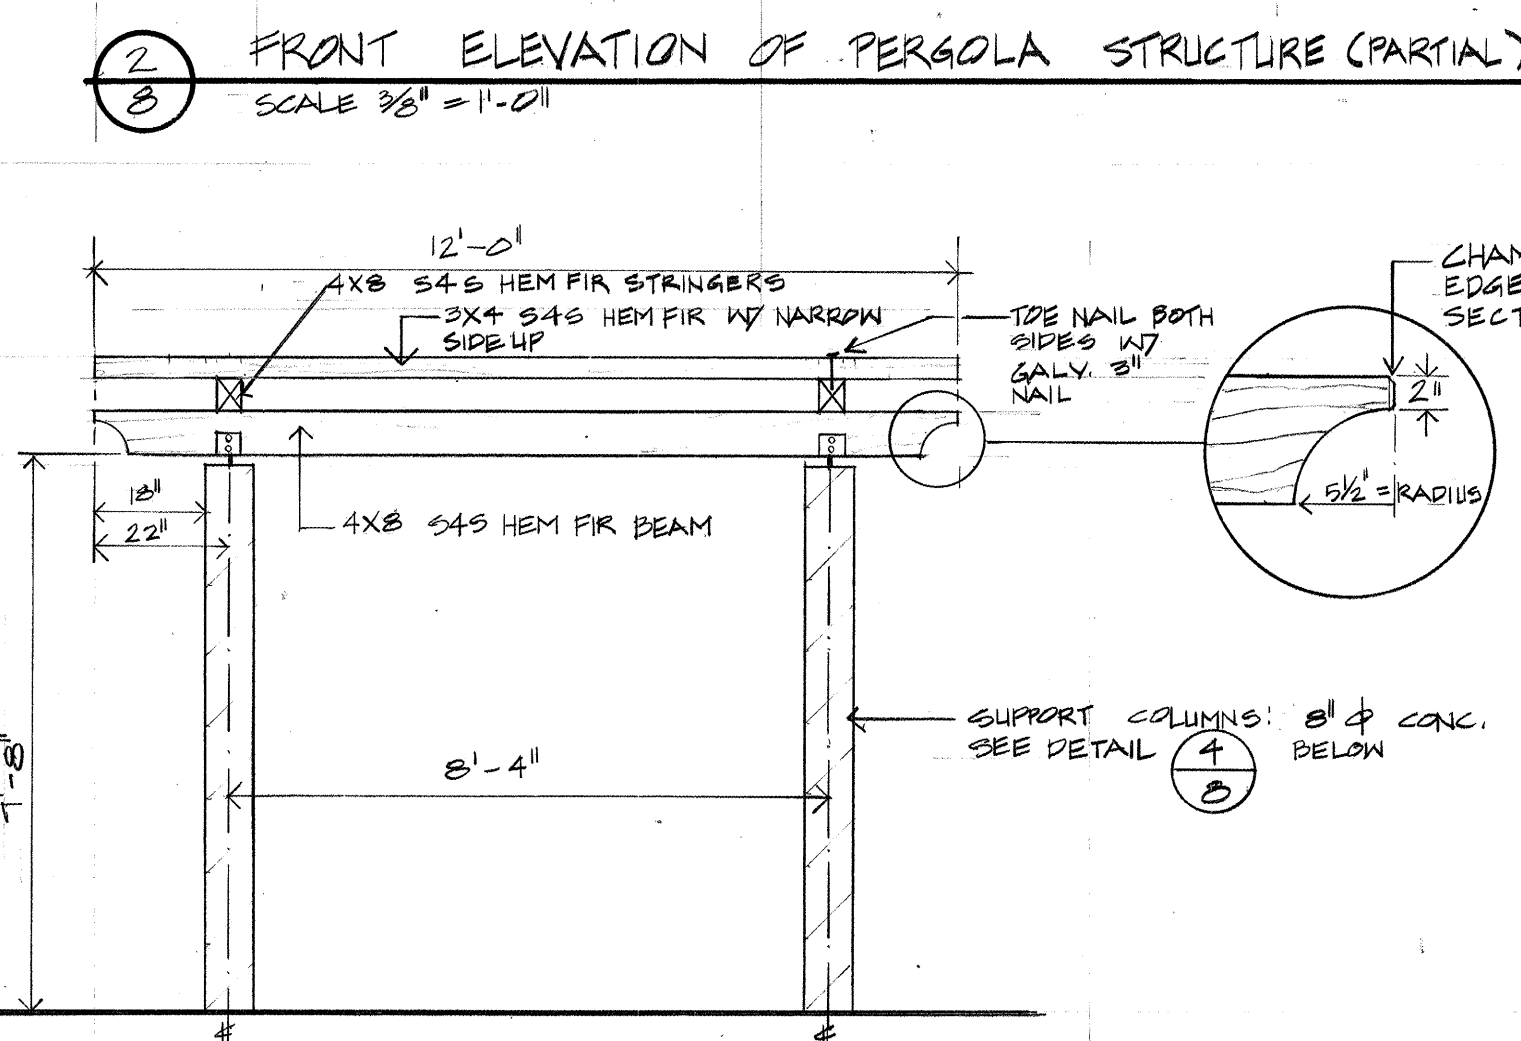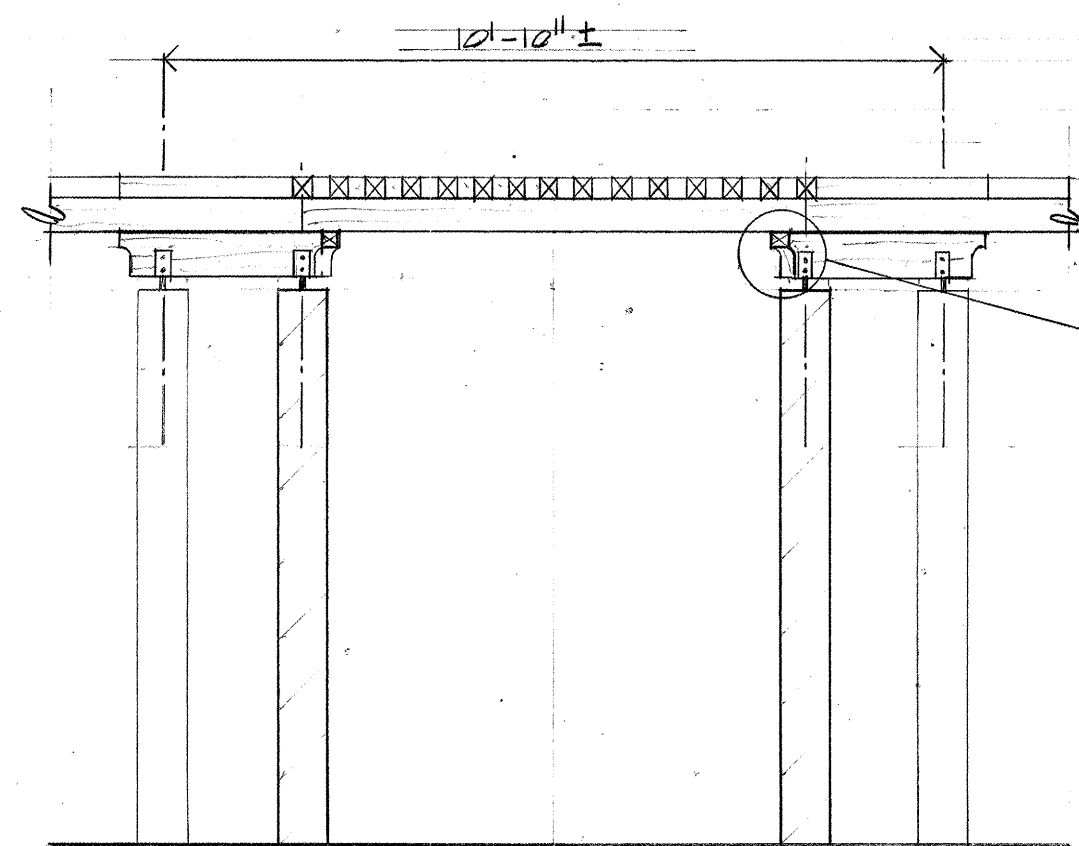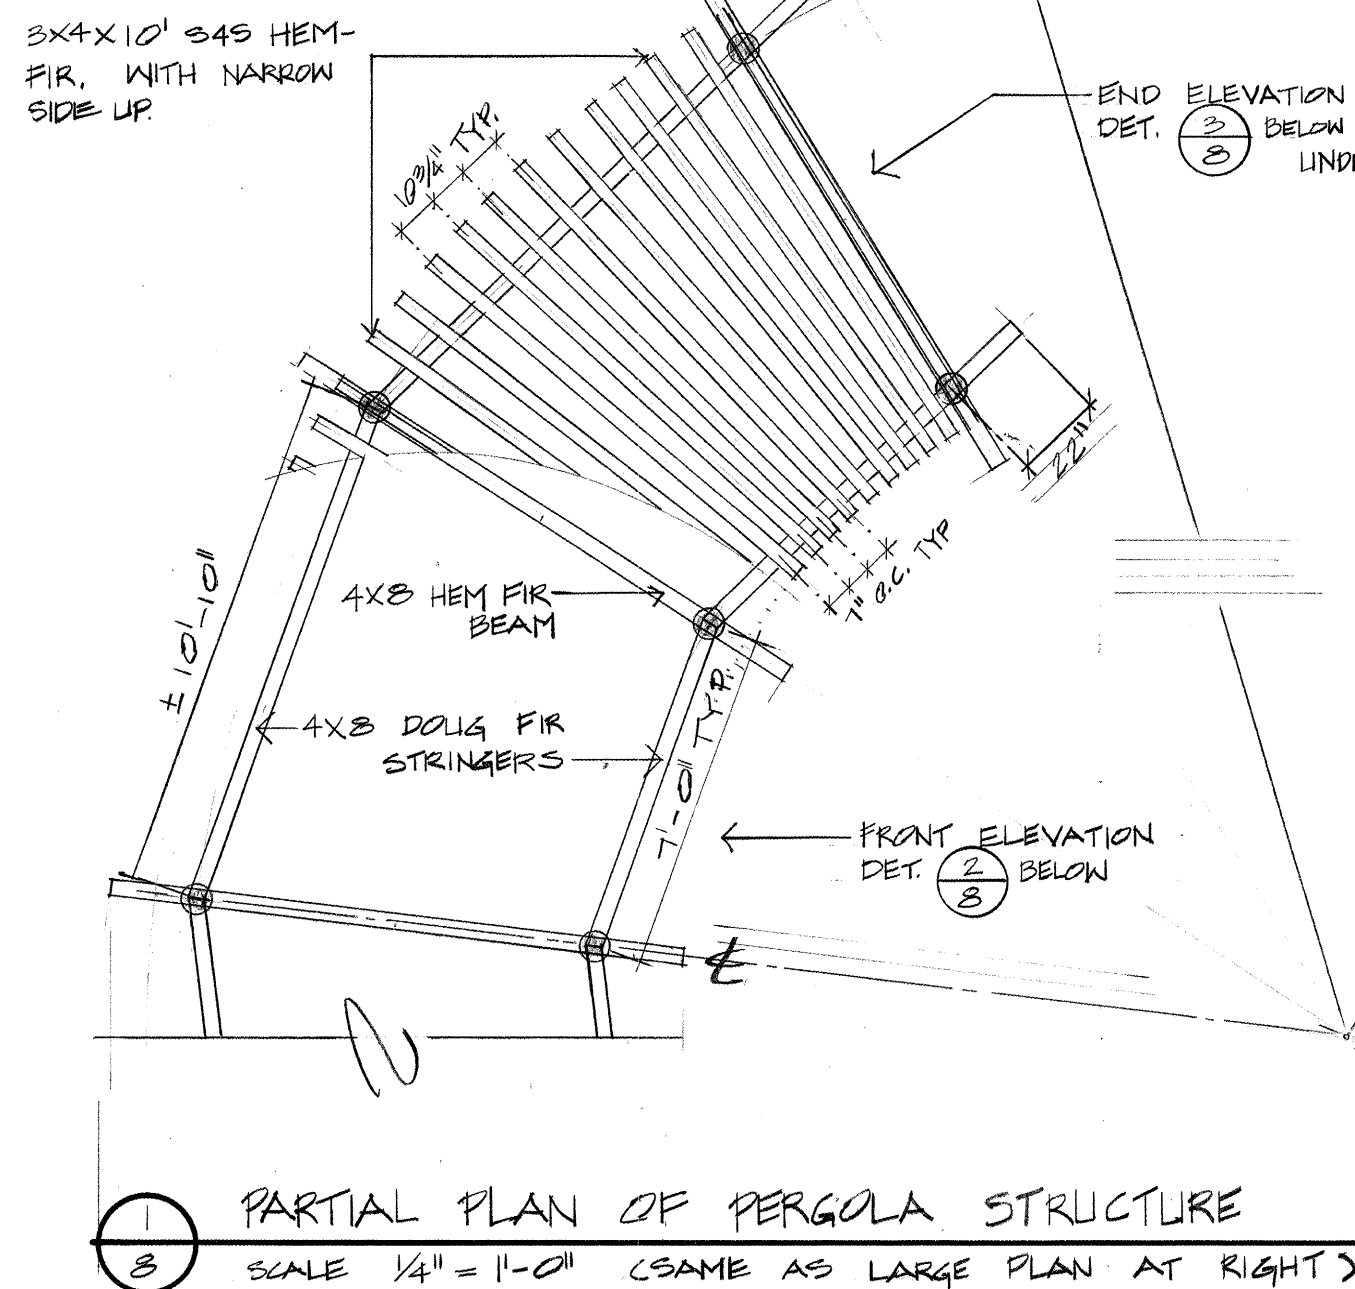


11 SECTION 'C-C' TREE GRATE PLAN
NO SCALE

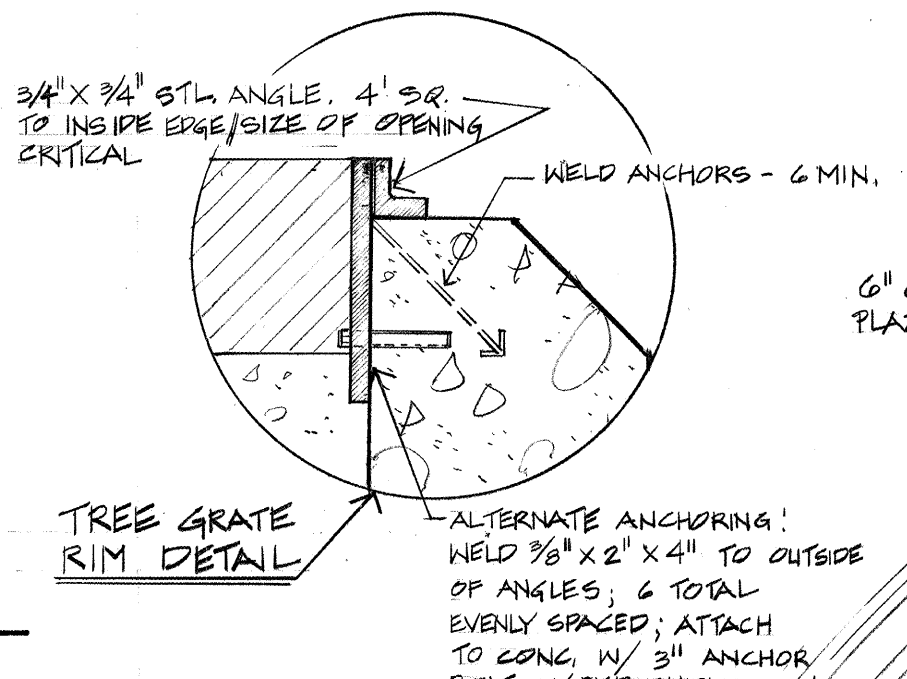


12 TREE GRATE PLAN
NO SCALE

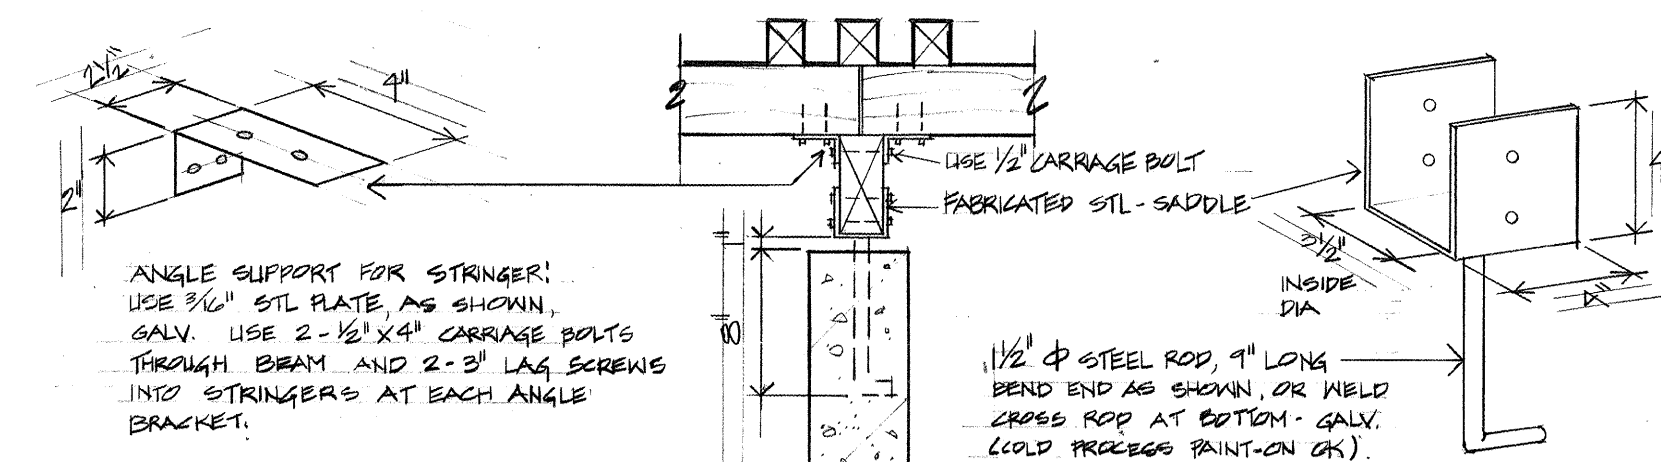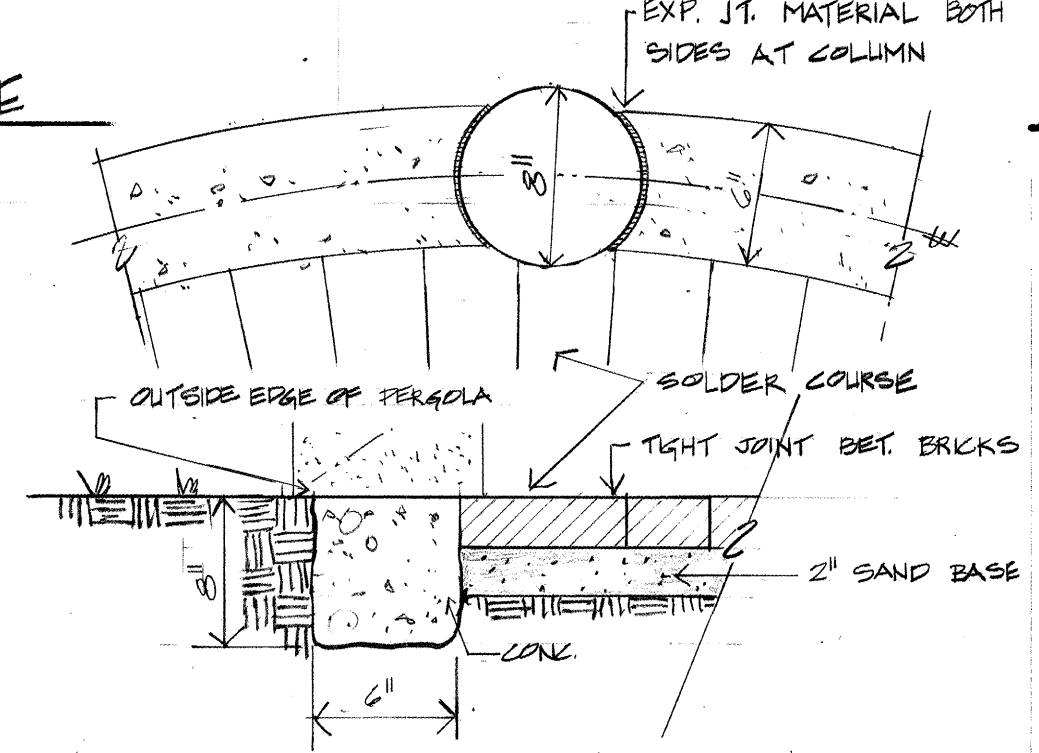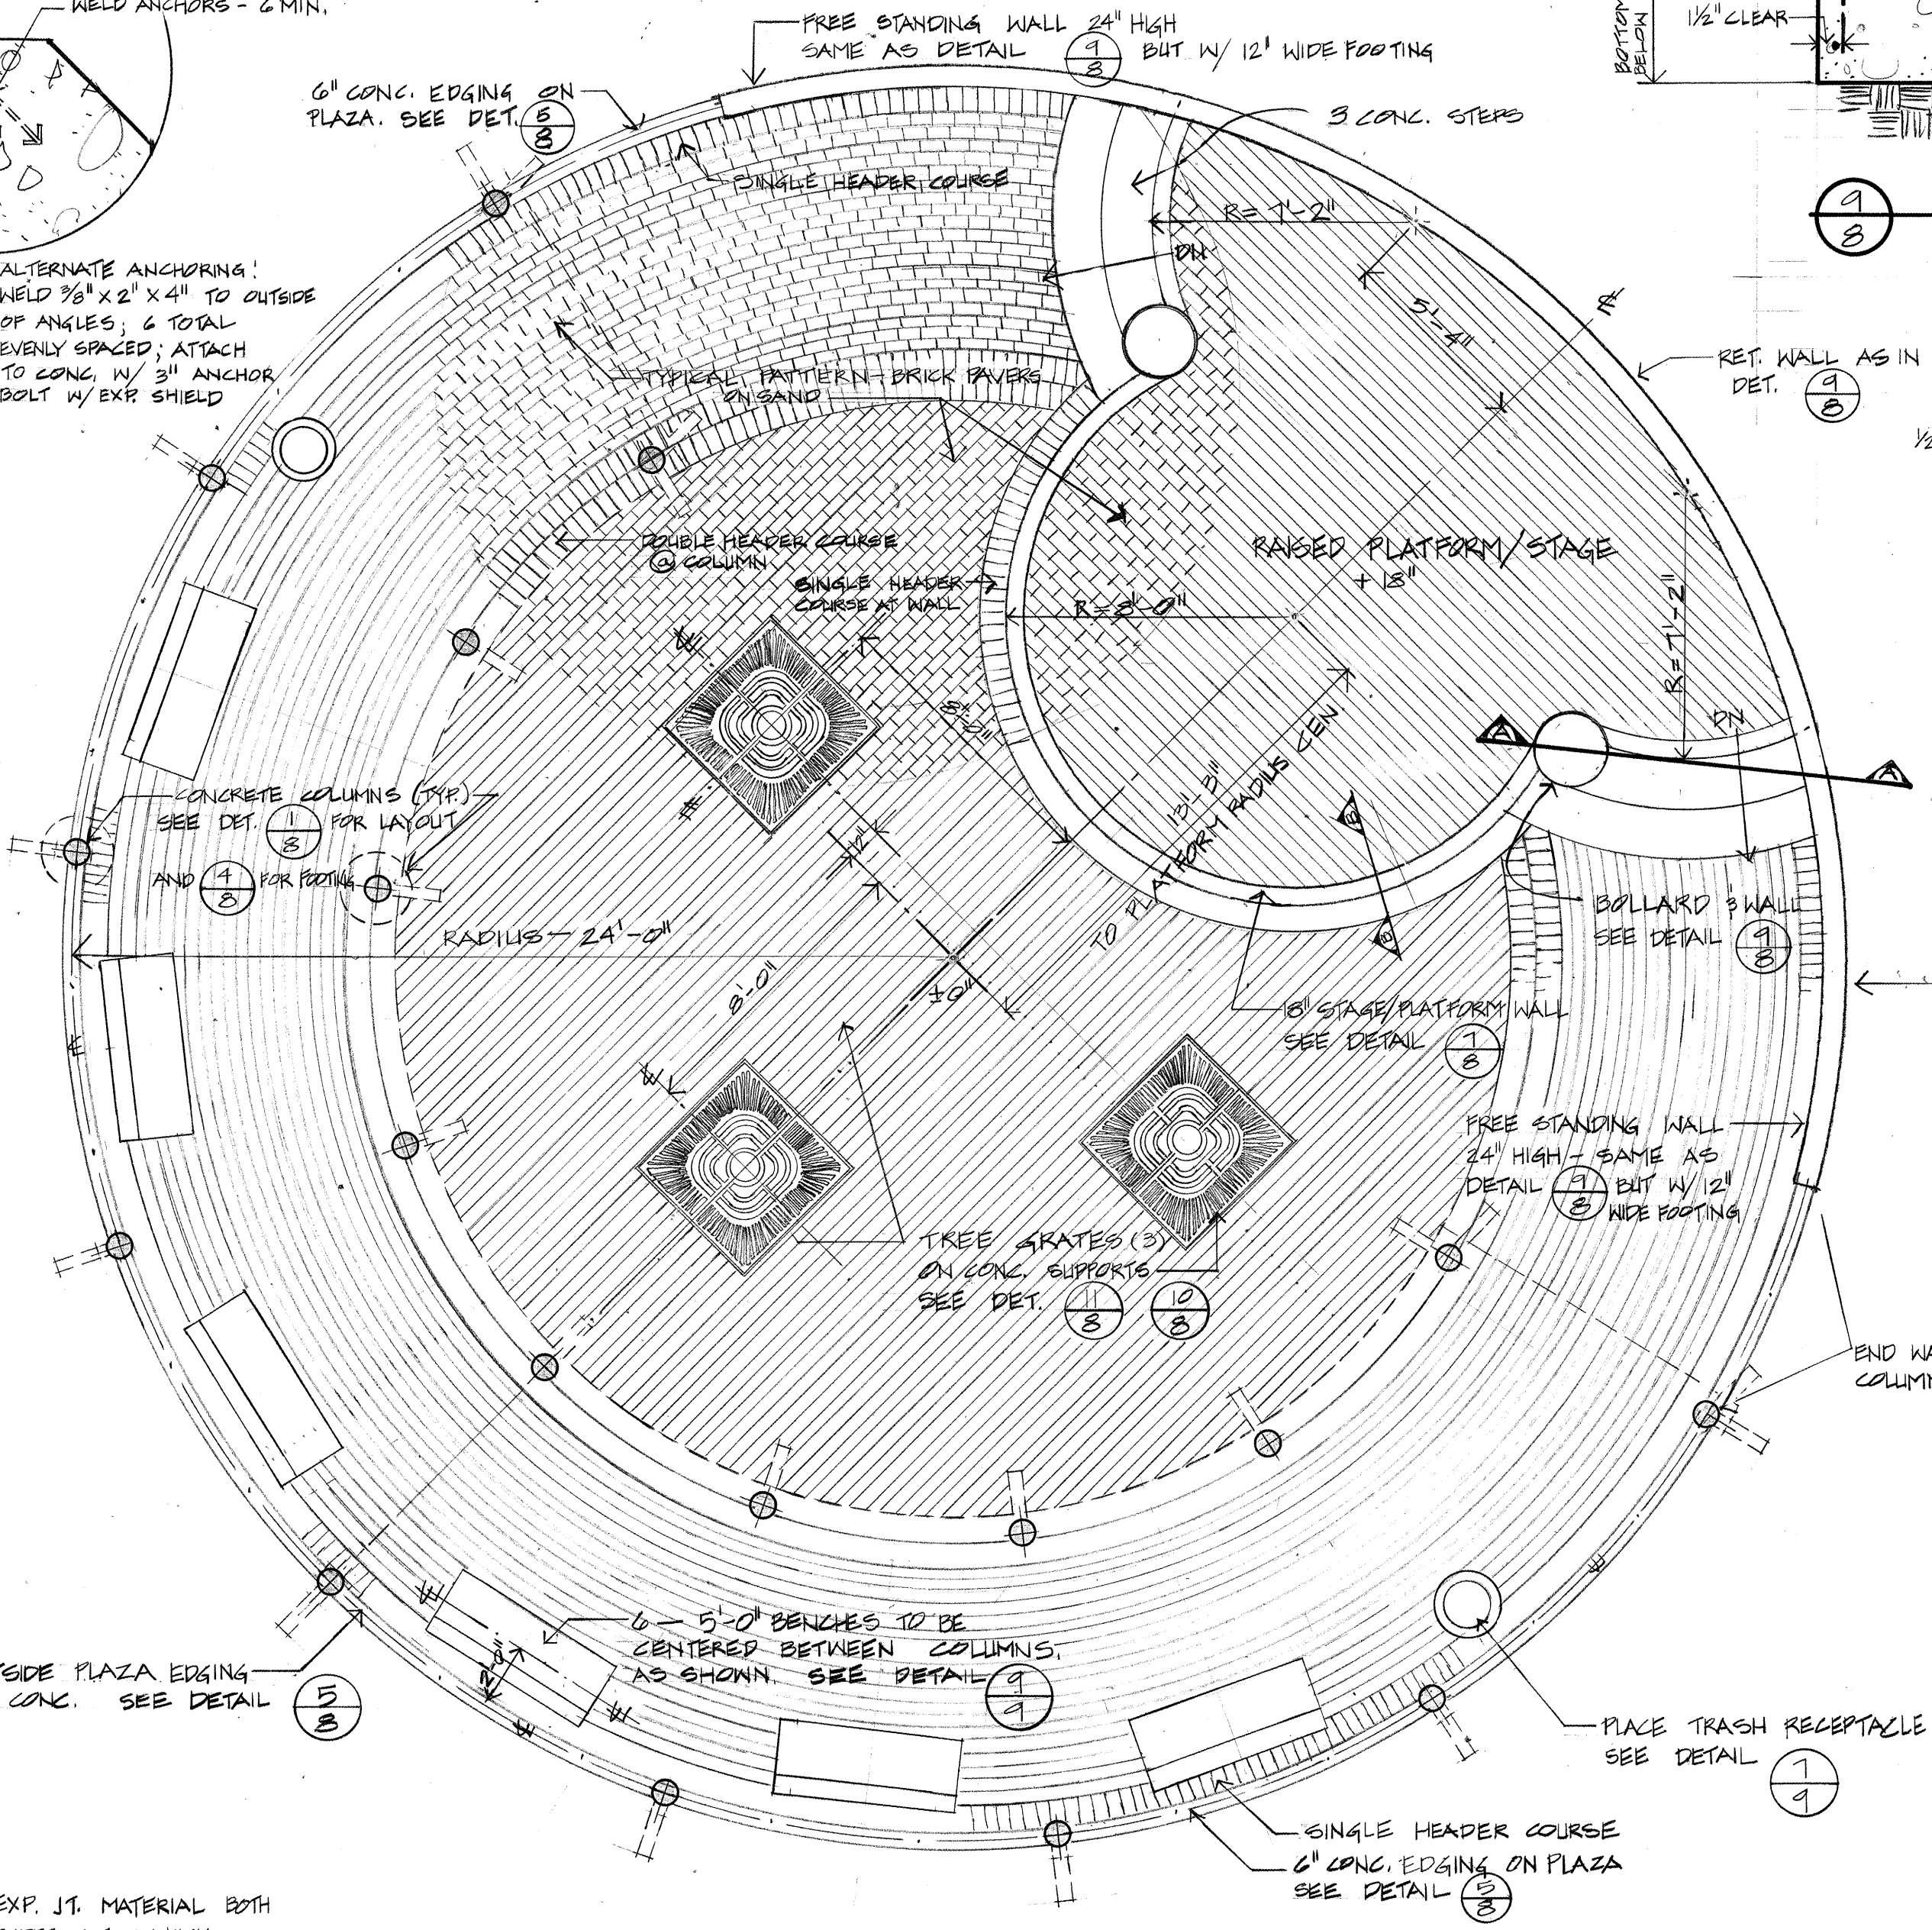


1' SR TREE GRATE AVAILABLE: URBAN ACCESSORIES FIRST / AVE. A SONOMIGH, WIS. (206) 268-2055

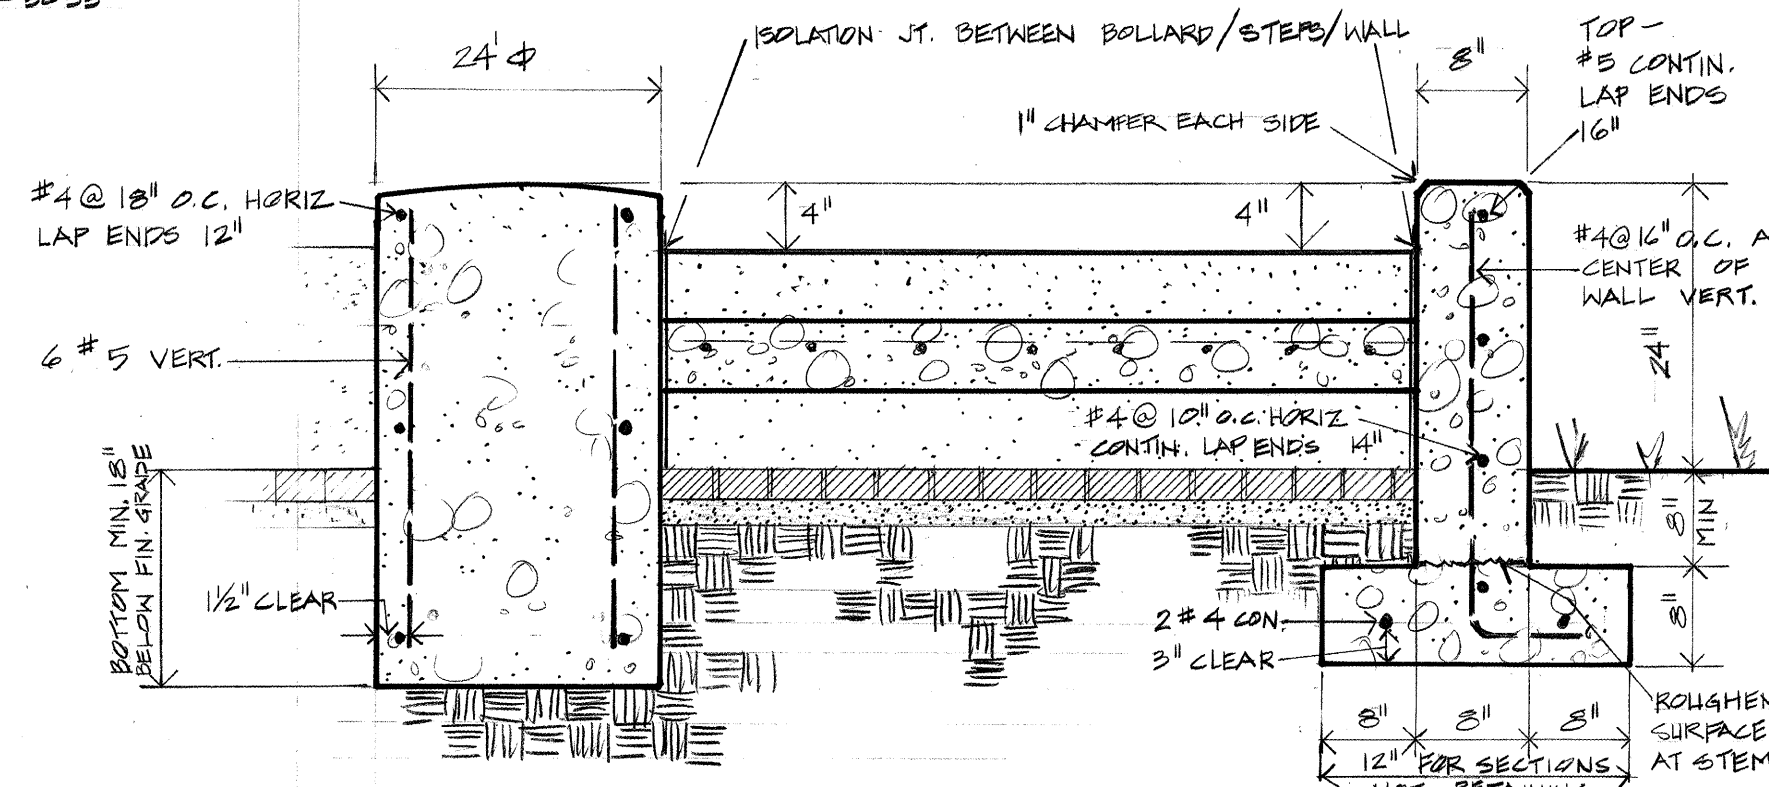

1 SECTION 'A-A' THROUGH BOLLARD & STAGE STEPS
SCALE 3/4" = 1'-0"

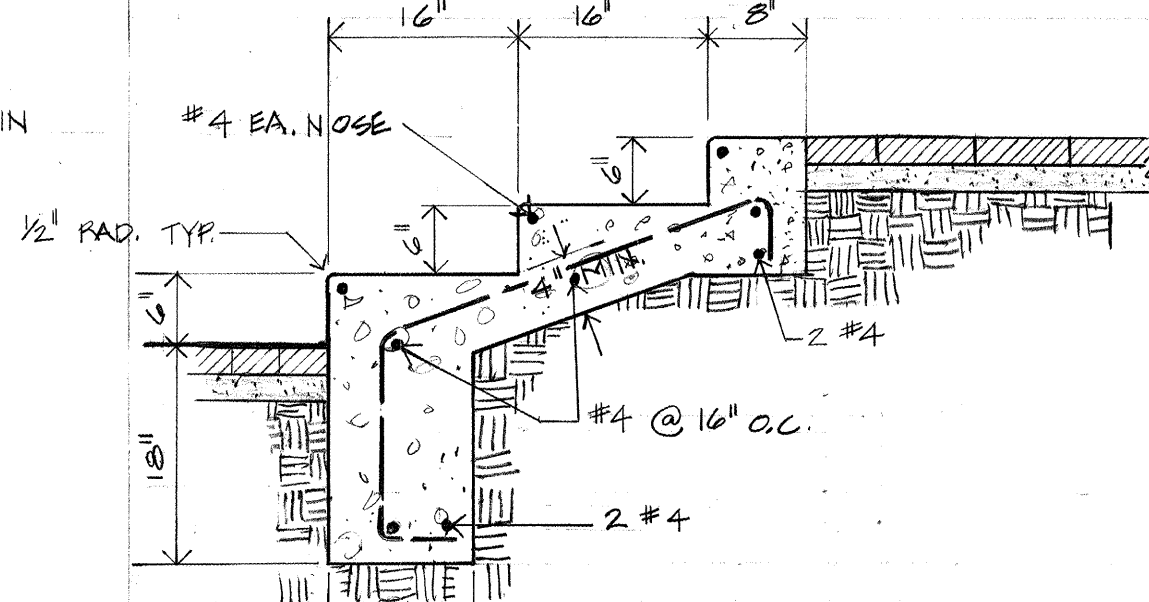

2 SECTION THROUGH STAGE STEPS
SCALE 3/4" = 1'-0"

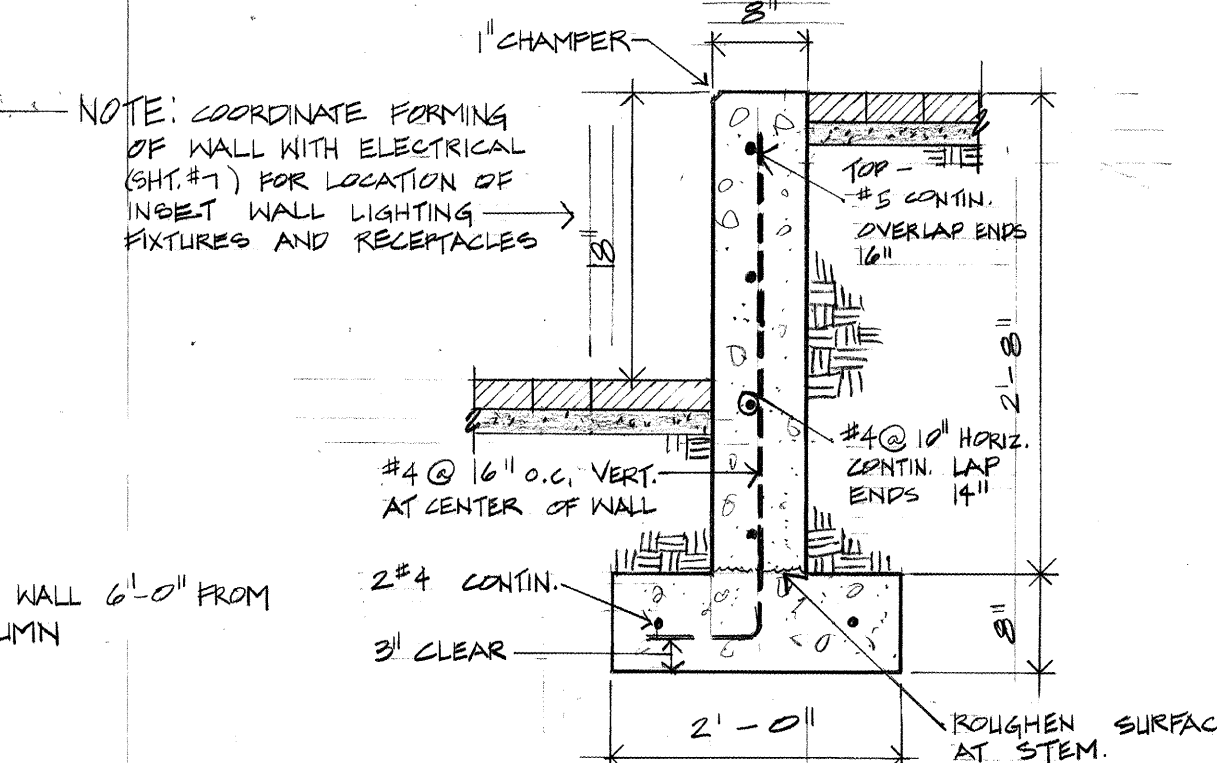

1 SECTION 'B-B' THROUGH STAGE WALL
SCALE = N.T.S.

GENERAL NOTE: ALL EXPOSED CONCRETE ON THIS PROJECT, INCLUDING COLUMNS, SIDEWALKS, WALLS, ETC., TO HAVE INTEGRAL COLOR AS SPECIFIED IN TECHNICAL SPECIFICATIONS. COLOR SAMPLE PRODUCED FROM LOCAL PLANT MIX CONCRETE TO BE PROVIDED PRIOR TO POURING ANY CONCRETE.

FOR INFO. READ ONLY

FOR INFORMATION ONLY

pergola plaza details
mary fox park
albuquerque, nm

REVISIONS










craig campbell associates
landscape architects
site planners

ALBUQUERQUE · SANTA FE






SCALE: AS SHOWN
DATE: SEPT. '78
DRAWN: M.W. / F.O.
CHECKED: C.C.

SHEET NUMBER

8

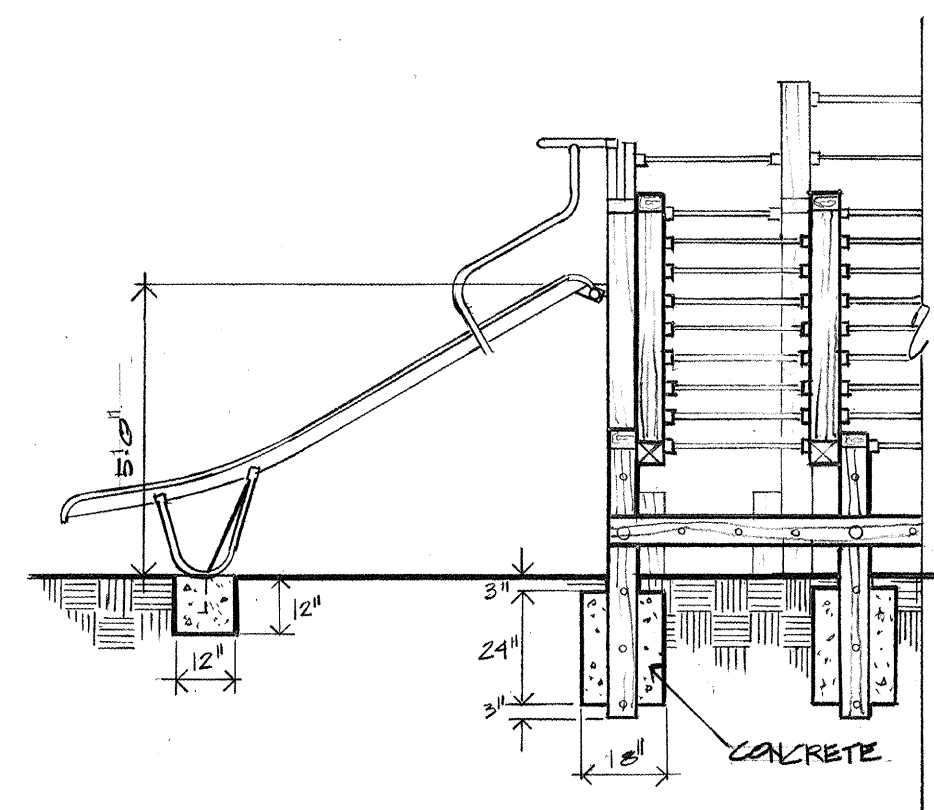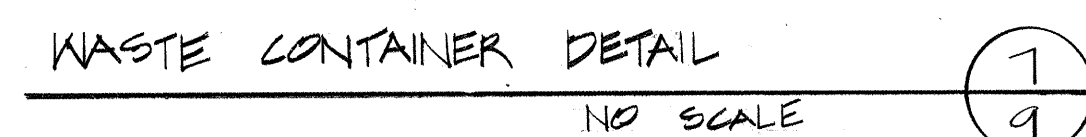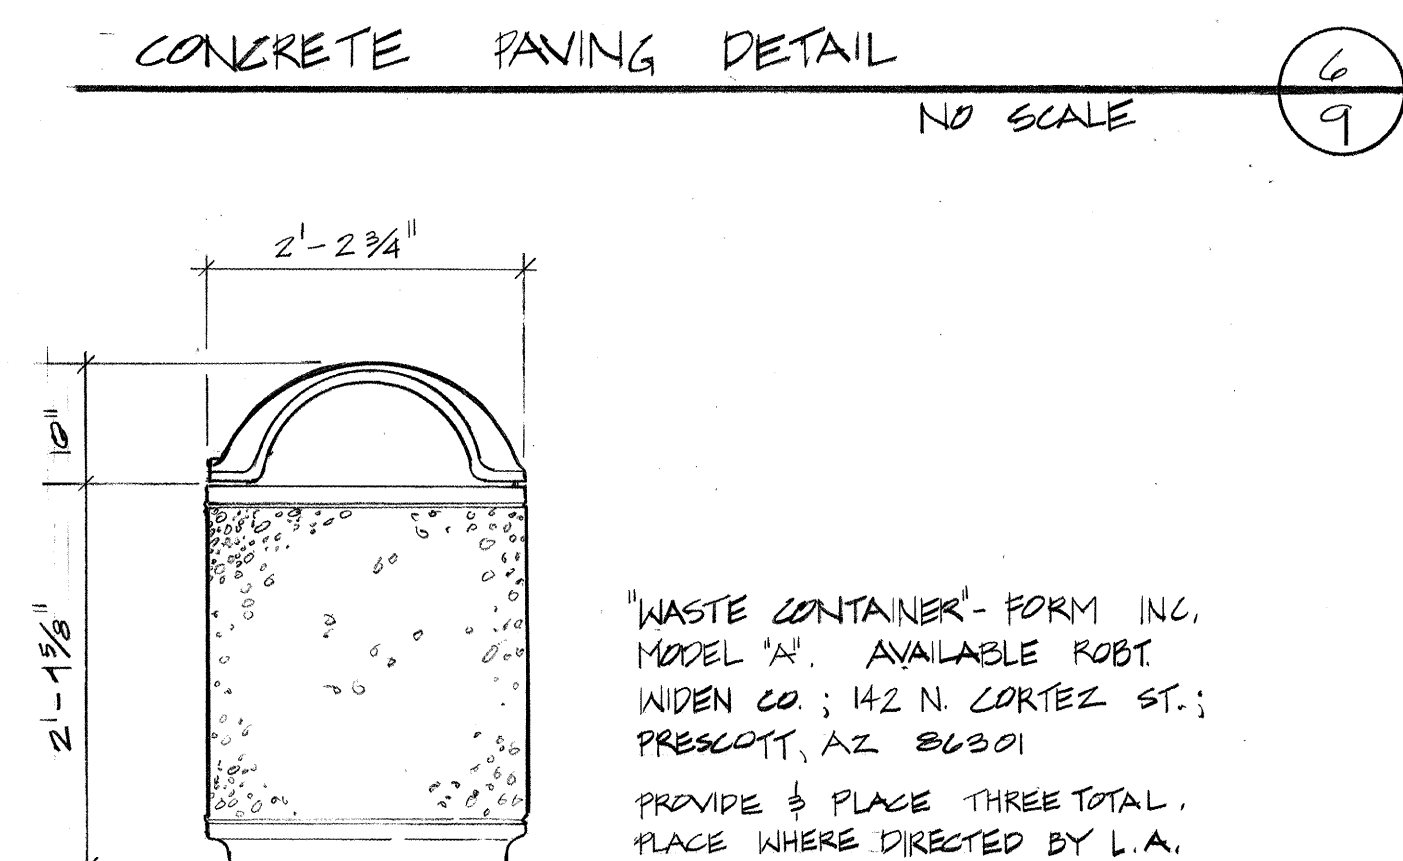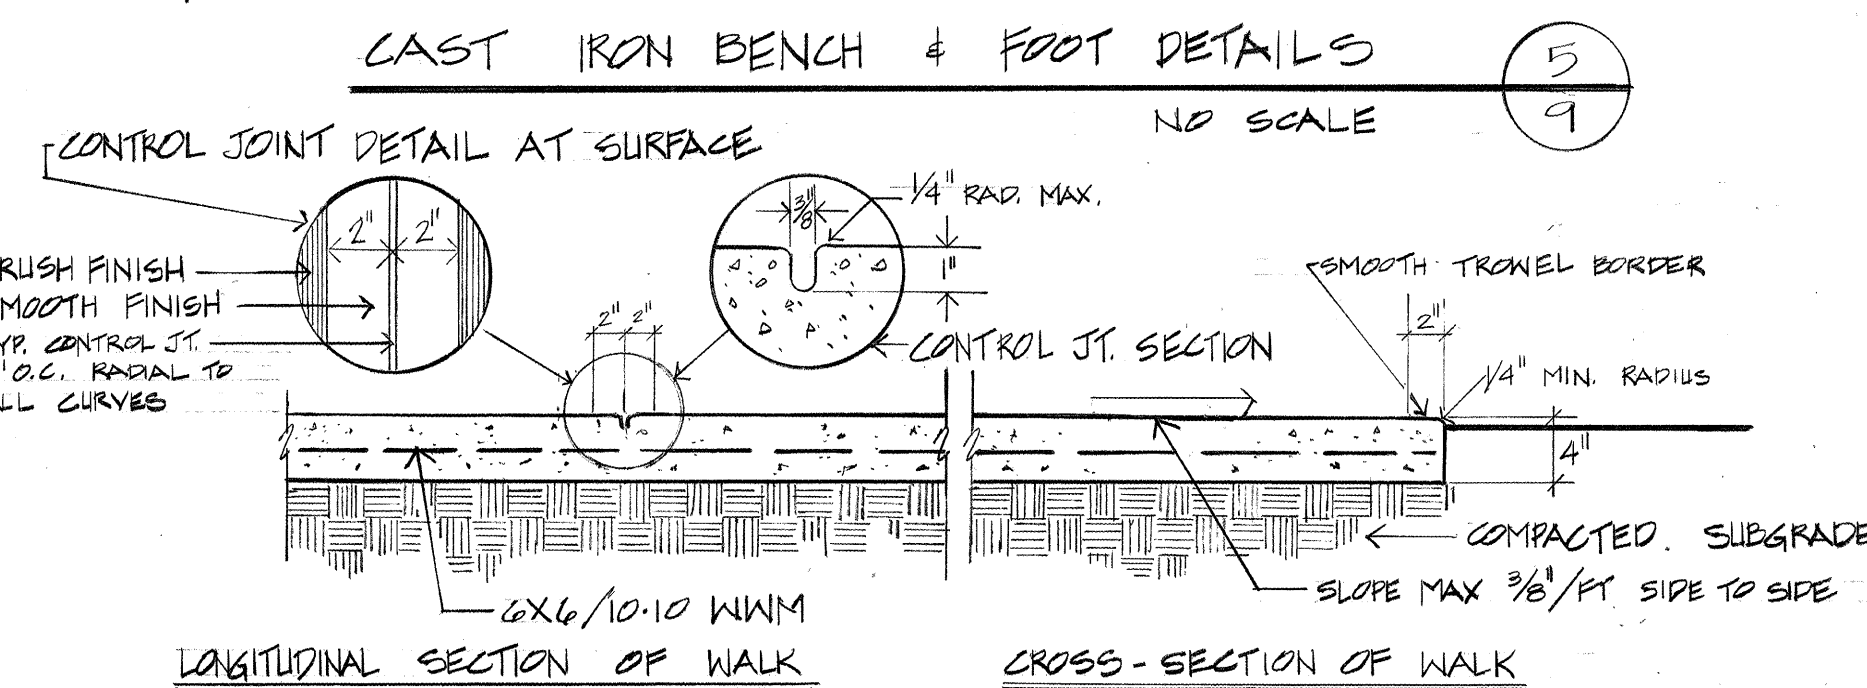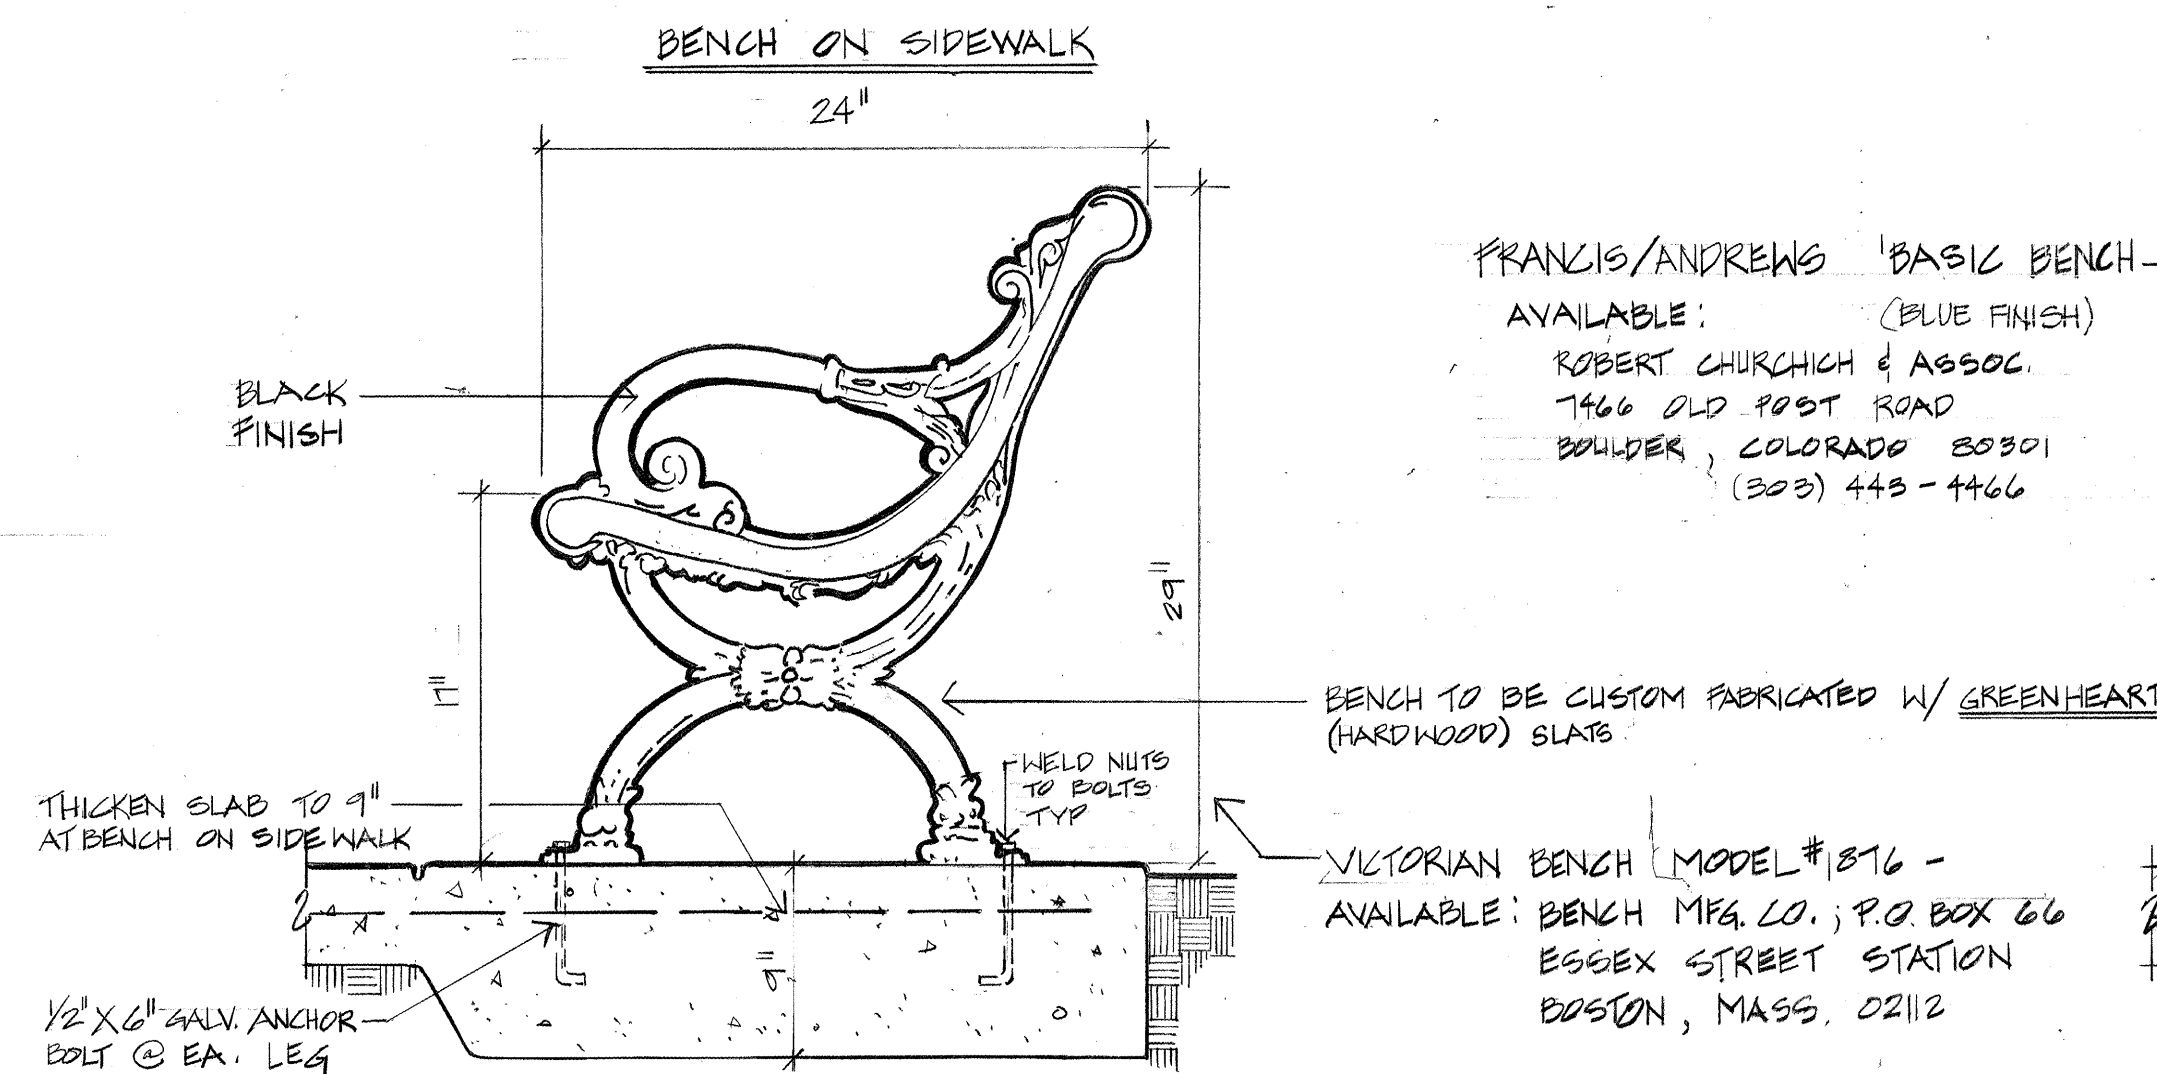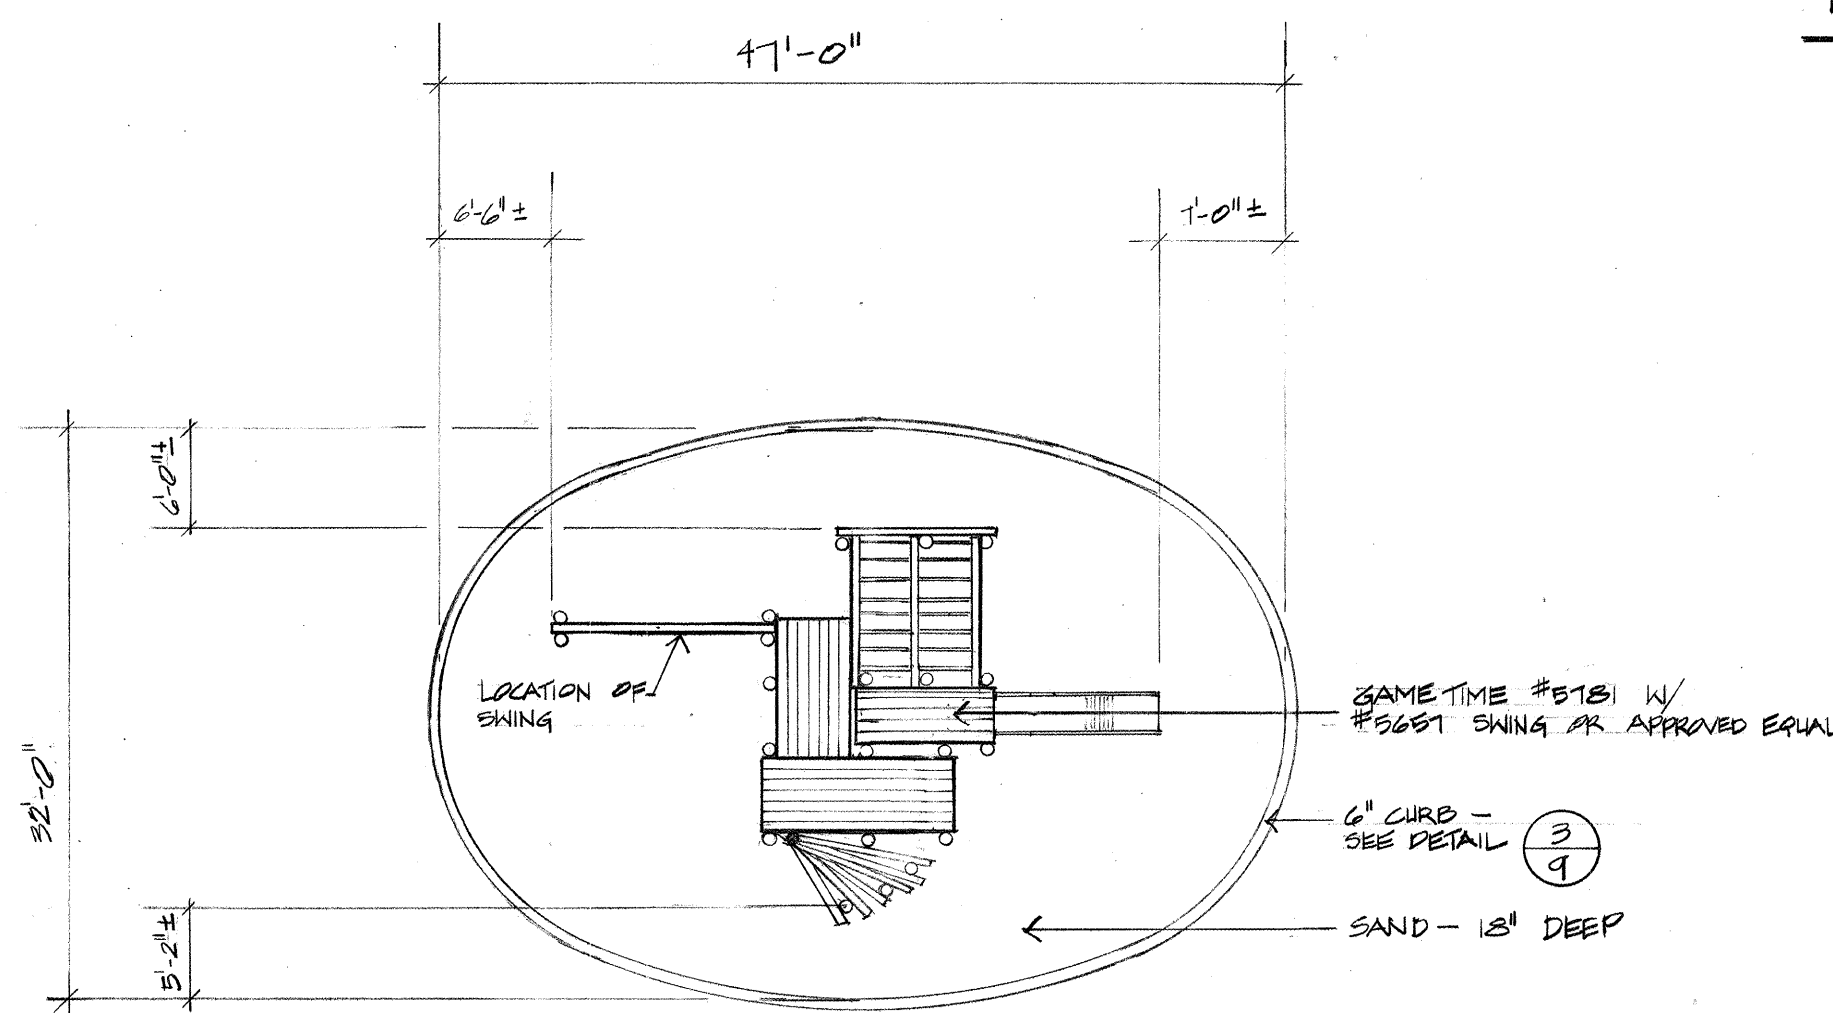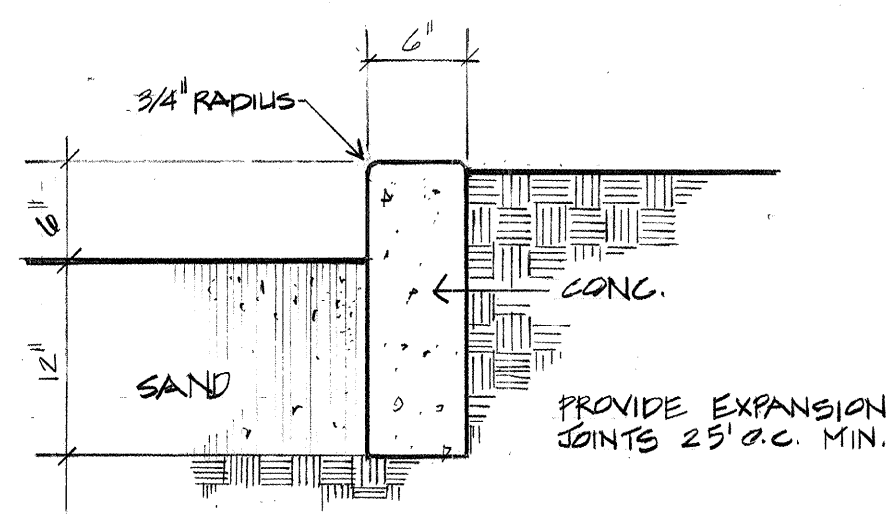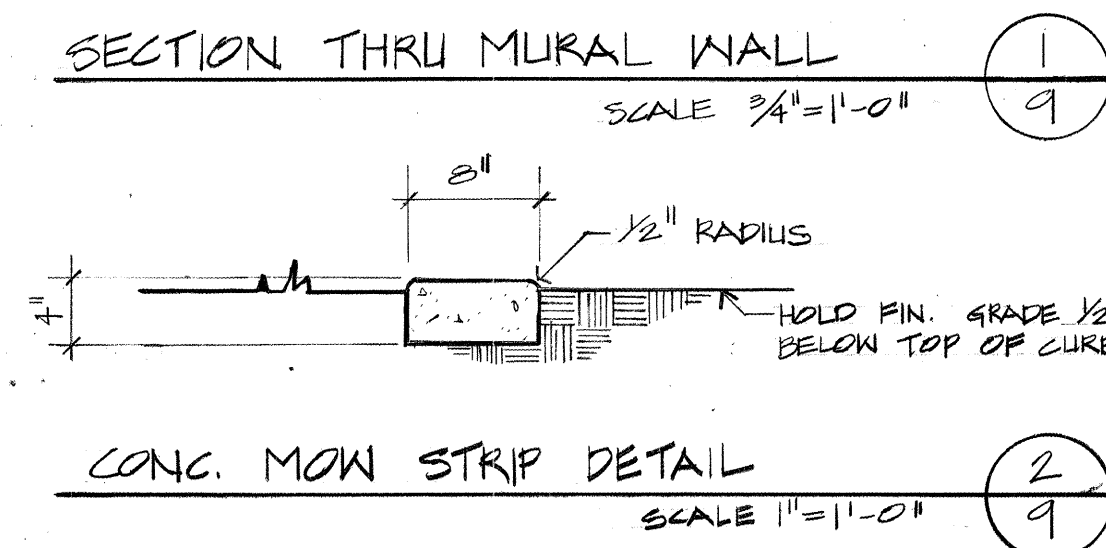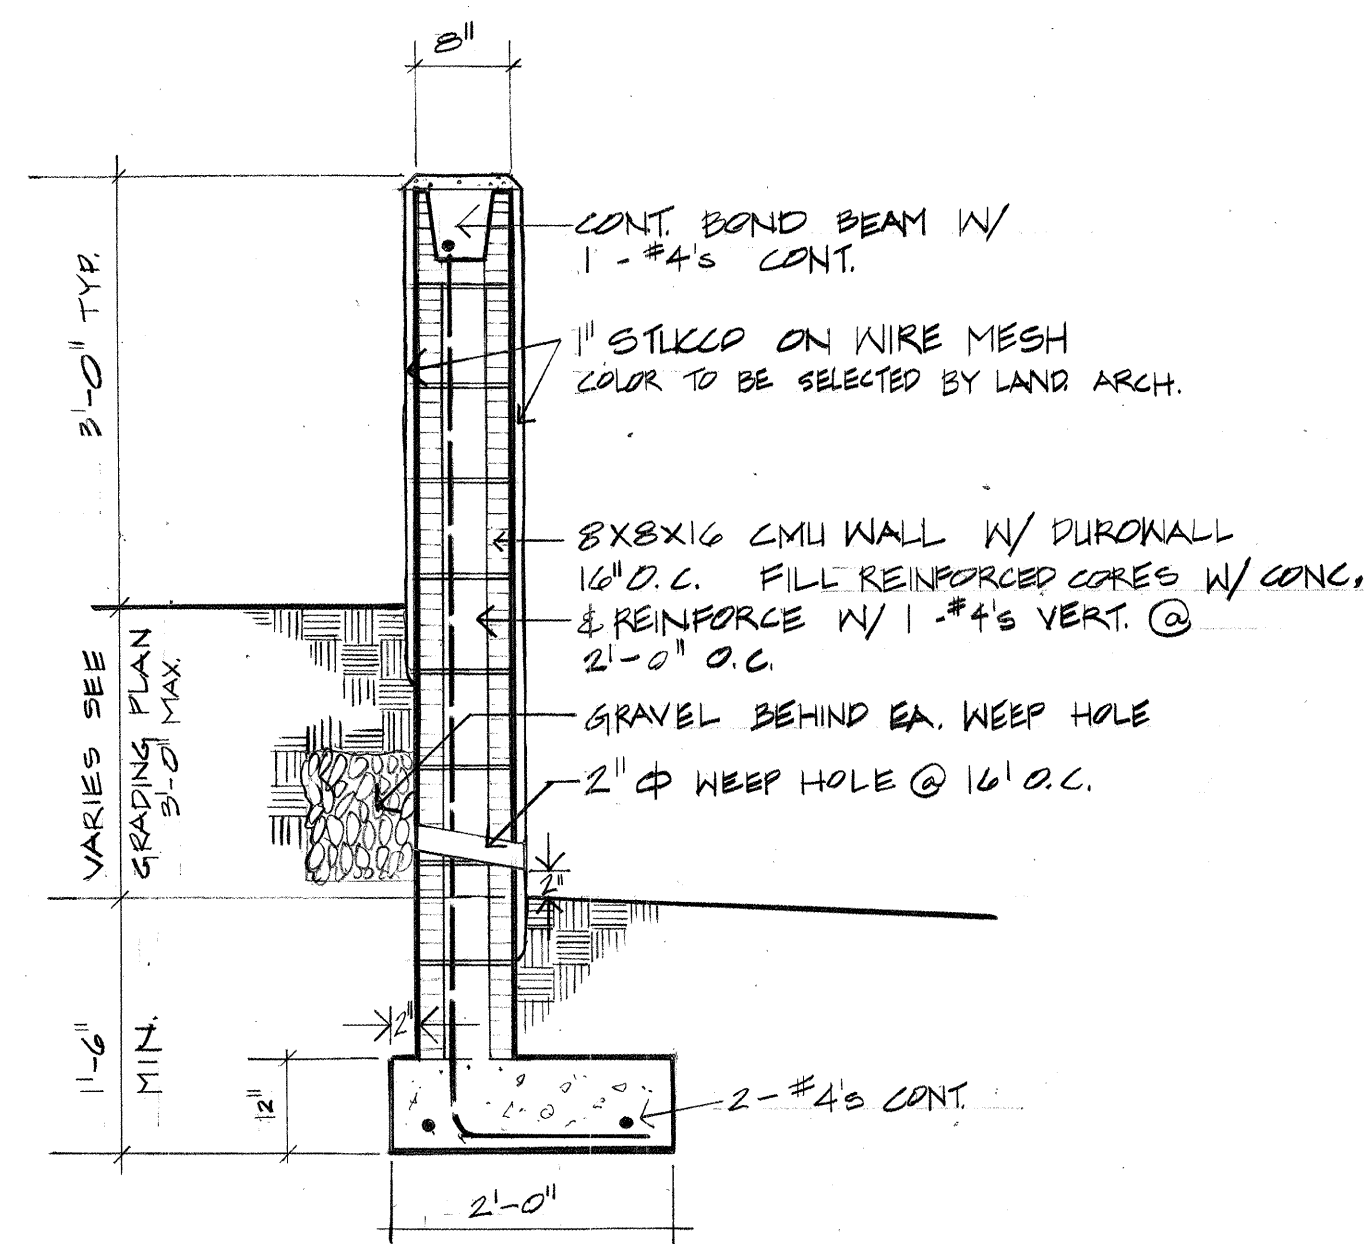

PLAY EQUIPMENT TO BE:
GAMETIME STAIRCASE CLIMBER #5131
W/ GAMETIME #5551 SWING
OR APPROVED EQUAL
AVAILABLE:
ROBERT WIDEN CO.
142 N. CORTAZ ST.
PRESCOTT, ARIZ. 86201
(602-445-7390)

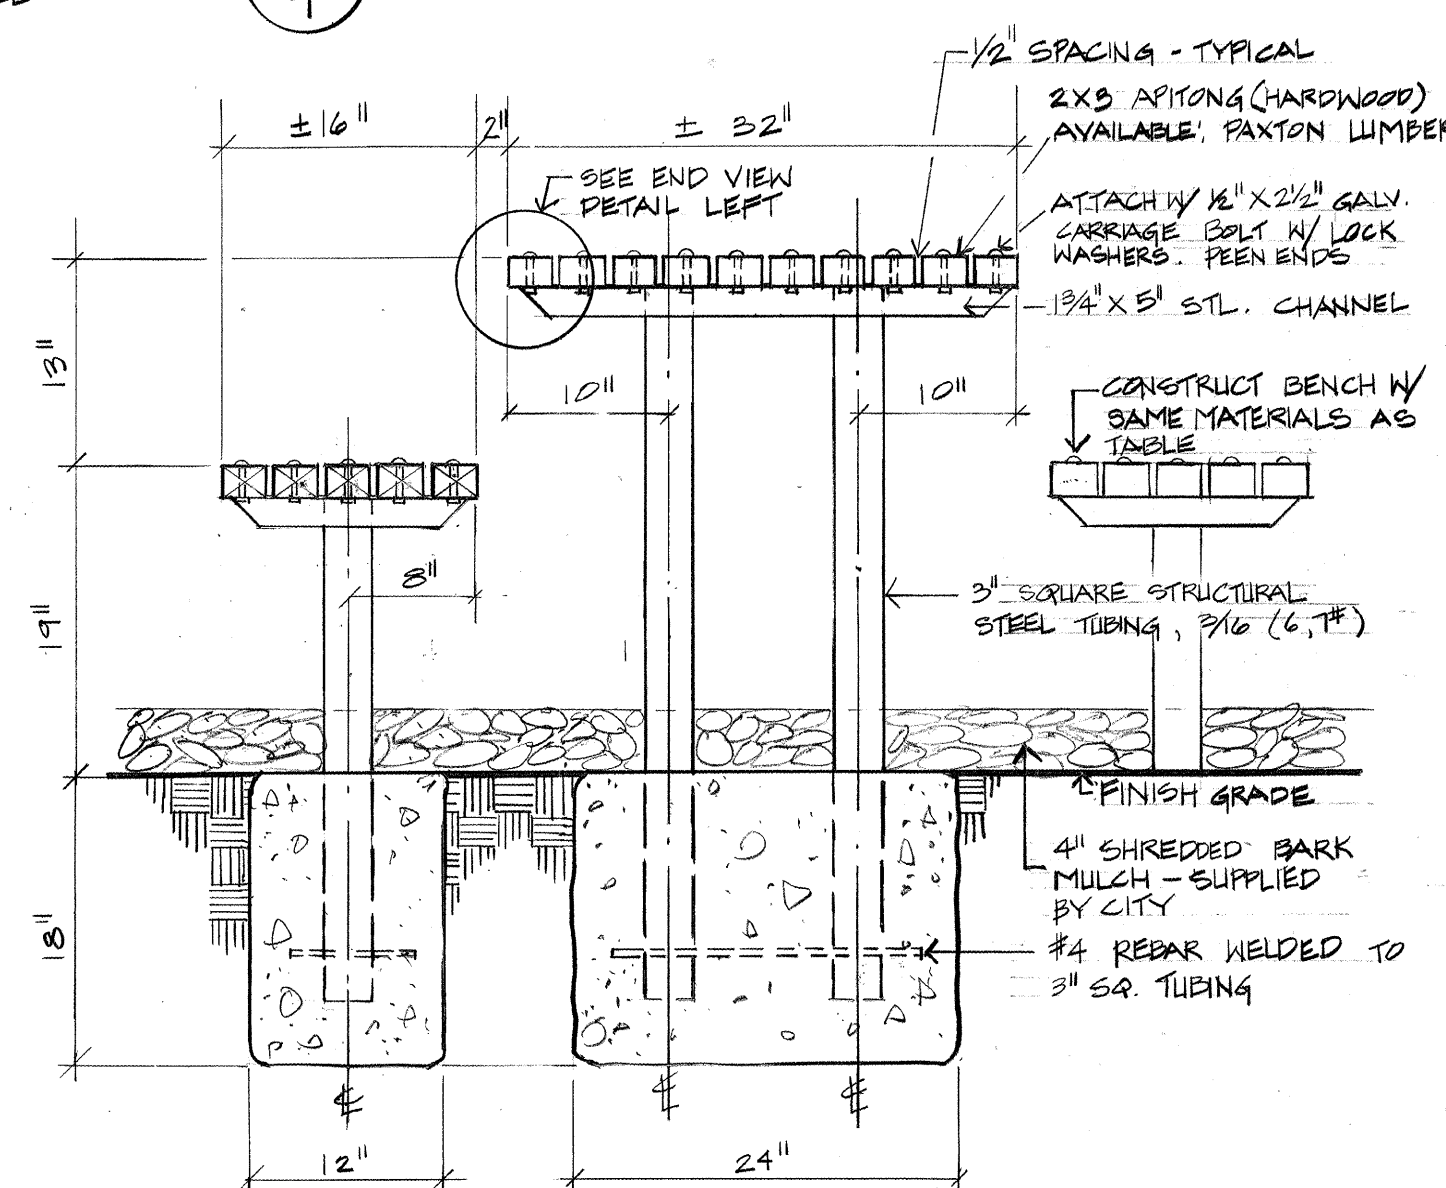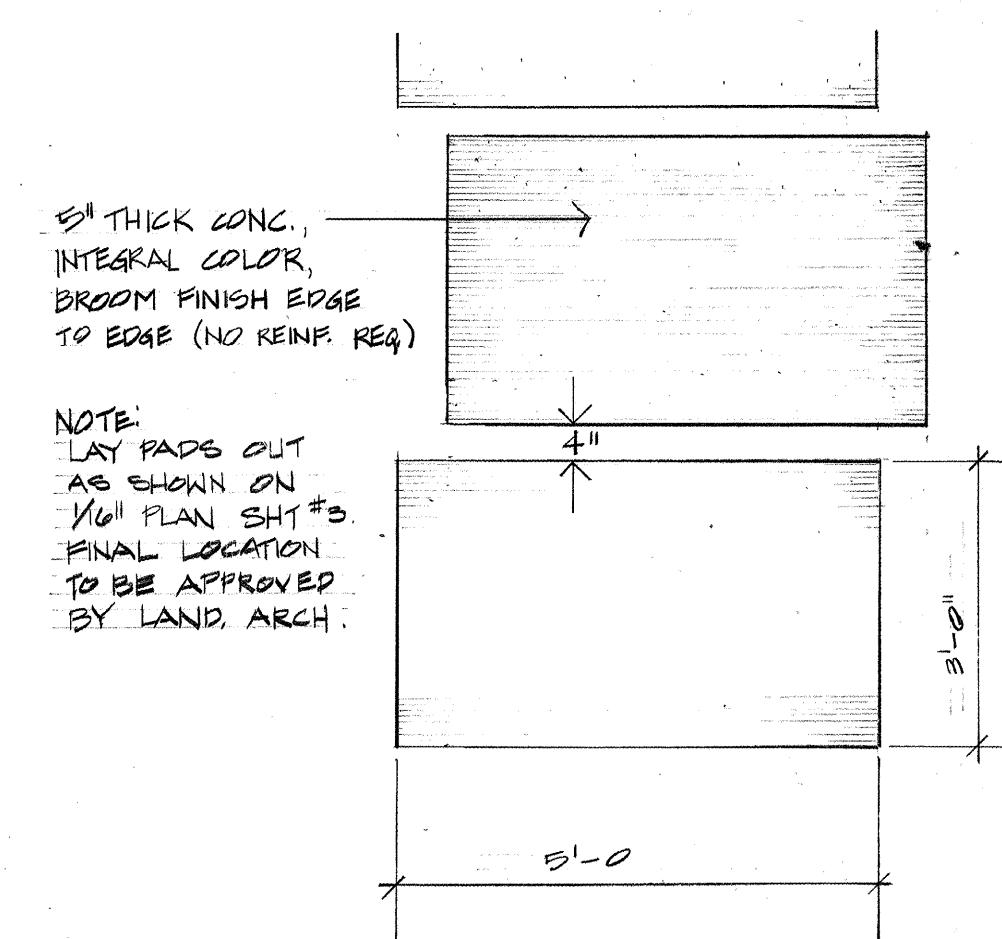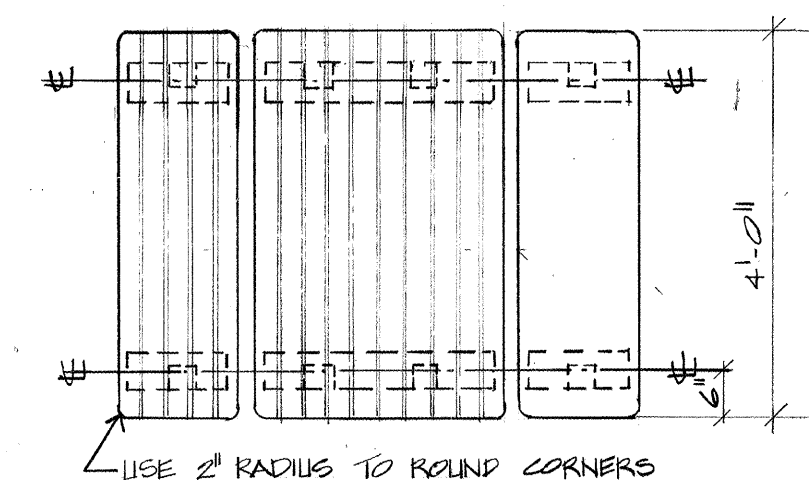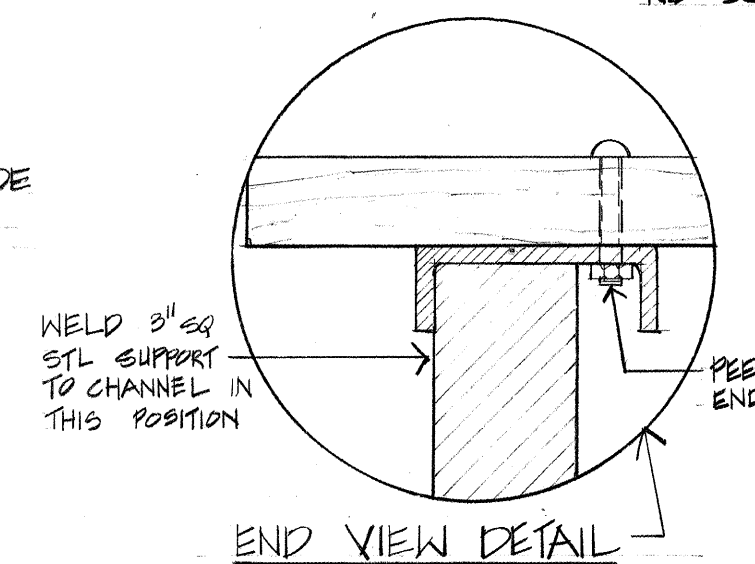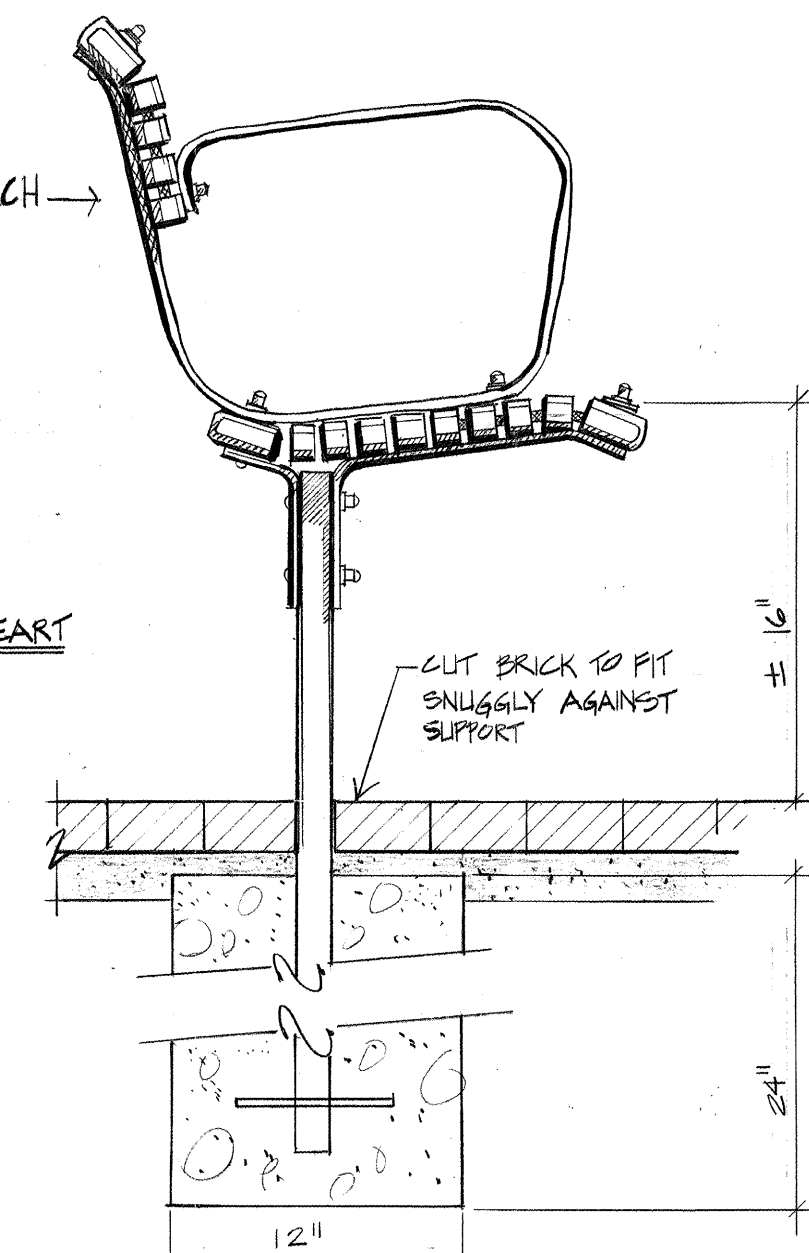

REVISIONS

craig
campbell
associates
landscape architects
site planners

ALBUQUERQUE • SANTA FE

SCALE: AS SHOWN
DATE: SEPT 1981
DRAWN: F.O.
CHECKED: G.C.

SHEET NUMBER

9

site details
mary fox park
albuquerque, nm

PUBLIC ALLEY

CONIFER FOREST
W/GRAVEL UNDER

LARGE TREES
STEPPING STONES

SHRUB BED

PERGOLA & FOUNTAIN

FLOWERING TREES
W/GRAVEL UNDER

CONC. WALK (TYP.)

14TH.

13TH.

R O M A

EXIST. TAMARISK
6' WALL W/MURAL

CONC. WALK (TYP.)
CHILDREN'S PLAY

DECIDUOUS FOREST
W/GRAVEL UNDER

STREET TREES
SHRUB BEDS
LARGE TREES

EXIST. ELM
EXIST. PINE
EXIST. MULBERRY


MARY
FOX
PARK

PRELIMINARY PLAN


FOR INFORMATION ONLY

REVISIONS

craig
campbell
associates

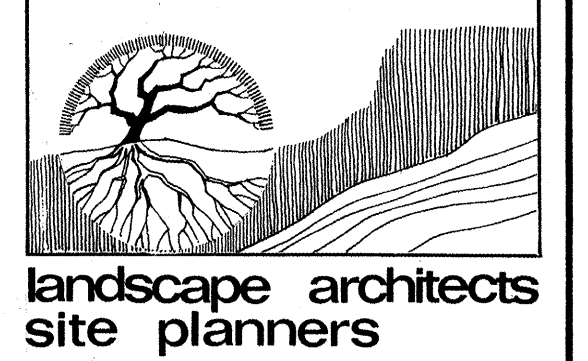

ALBUQUERQUE, SANTA FE

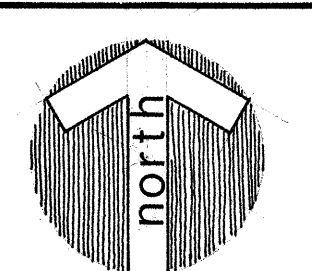

SCALE: 1"=16'
DATE: 5-24-78
DRAWN: m w
CHECKED: c c

SHEET NUMBER