
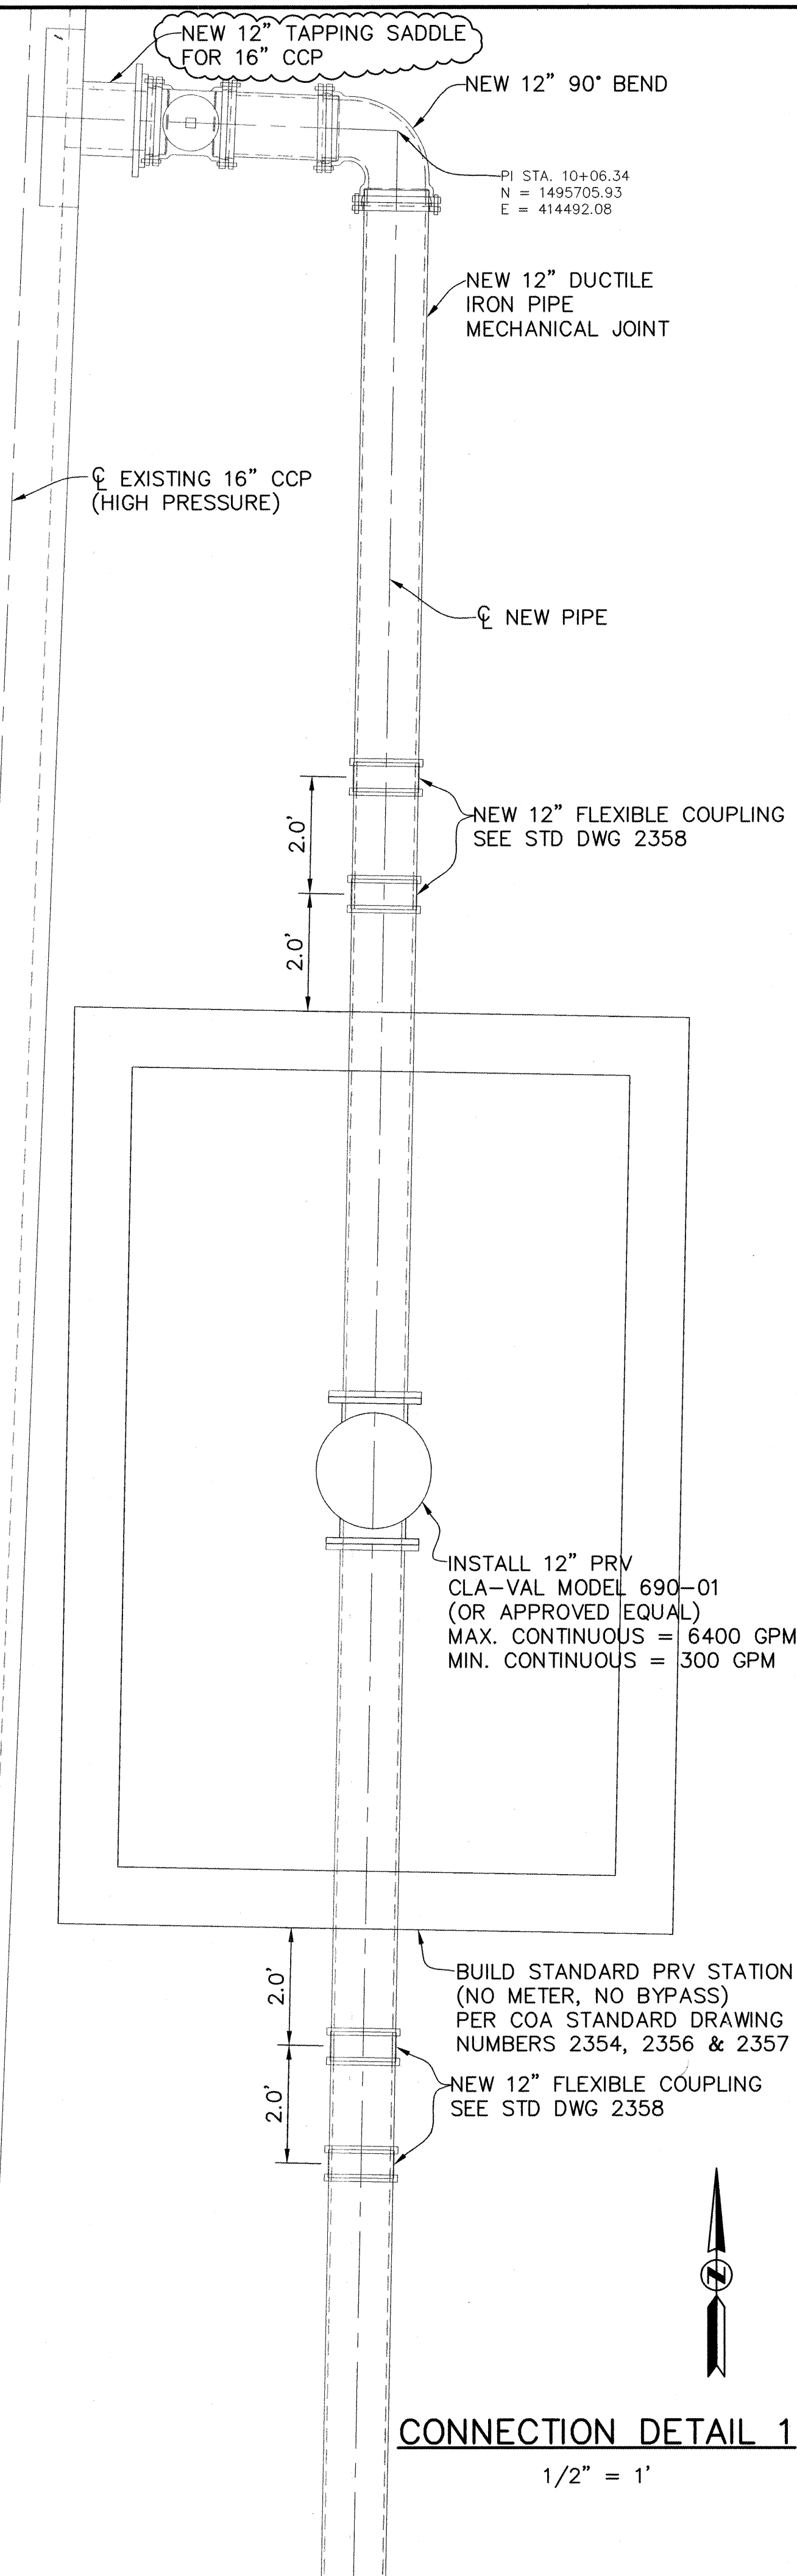




Drawing revised to reflect the best information available. Do not use without field verification

SCANNED BY
MESA REPRO

Date: Jun 30, 2005 - 9:14am jgarcia Layout: PIPING PLAN
Drawing Name: K:\PROJECTS\42985\015 PRV Relocation\CADD\42985015L01.dwg (For Internal Use Only)

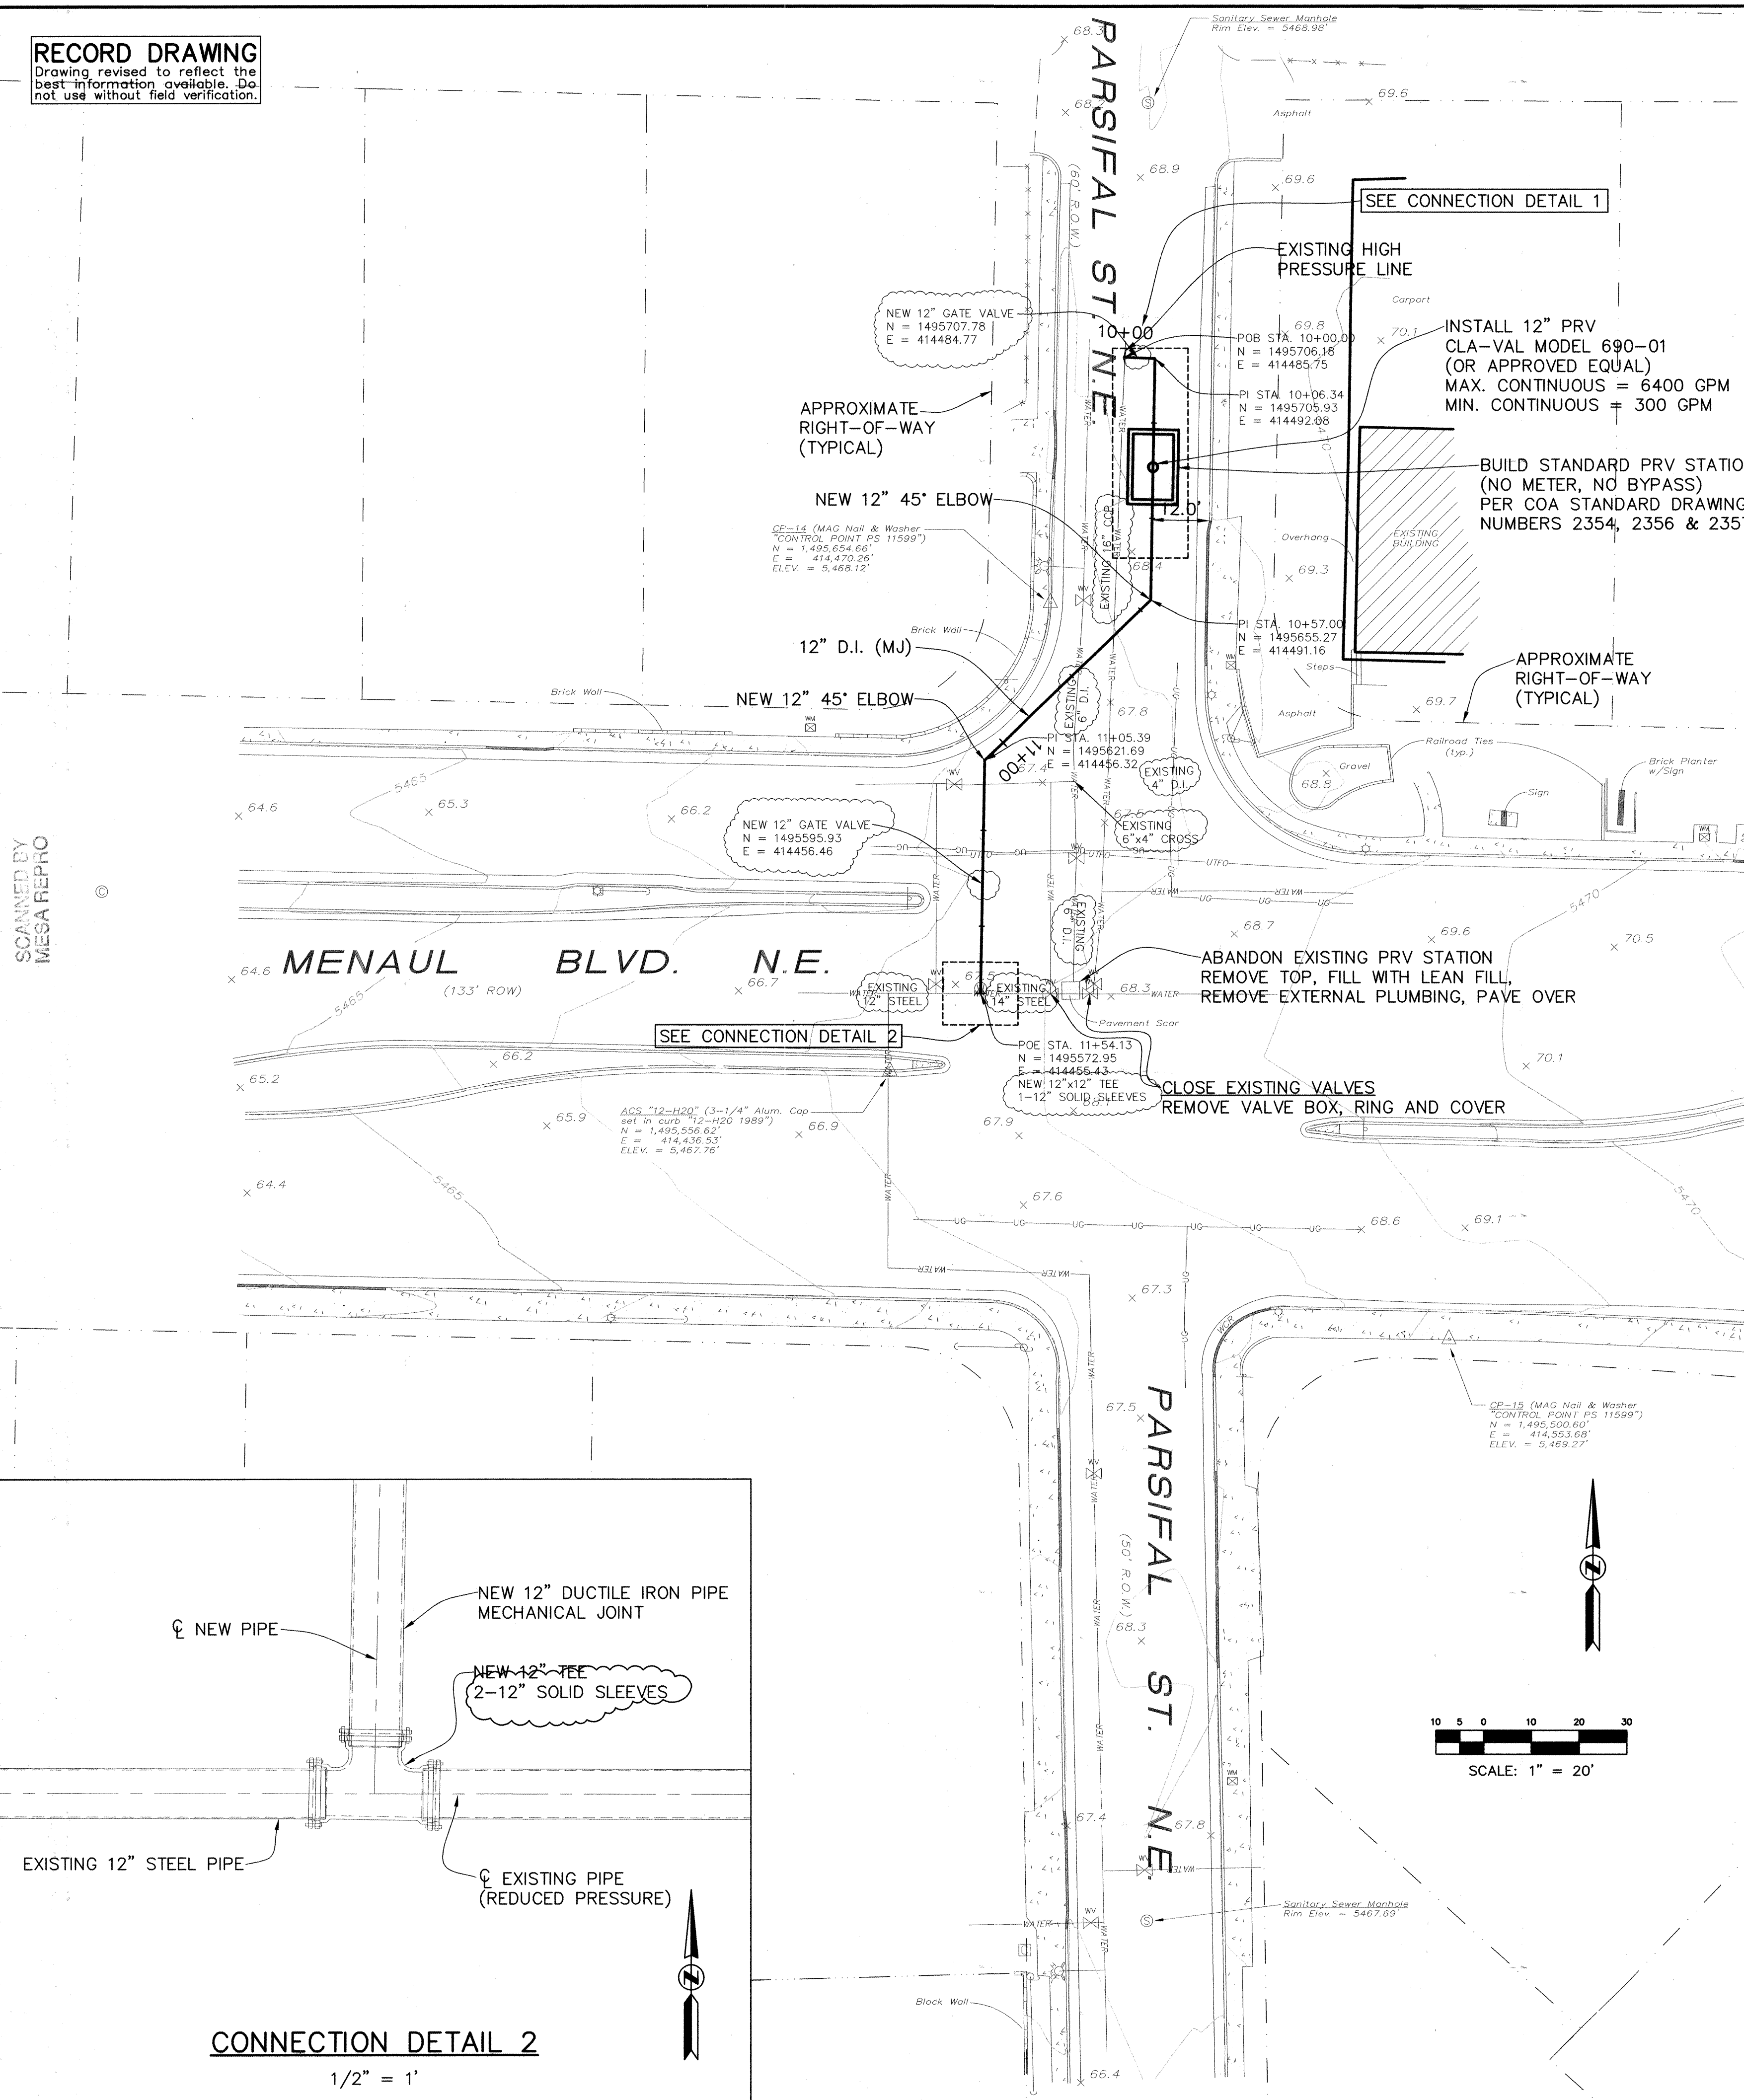

1. ALL NEW PIPE SHALL BE MECHANICAL JOINT DUCTILE IRON (WITH MEGA-LUG RESTRAINTS).
2. ALL BLOCKING SHALL BE AS SHOWN IN ACCORDANCE WITH CITY OF ALBUQUERQUE (COA) STANDARD DRAWING NO. 2320.
3. PRV STATION SHALL BE IN ACCORDANCE WITH COA STANDARD DRAWING NO. 2357 FOR PIPE SIZE 12". STANDARD PRV, NO METER WITH BYPASS. NO BYPASS REQUIRE STRUCTURAL DETAILS SHALL BE FOR TRAFFIC LOADING.
4. ACCESS HATCH SHALL BE 36"x36" HALLIDAY MODEL H1W3636 DESIGNED FOR TRAFFIC LOADING.
5. PRV ACCESS HATCH SHALL BE 48"x48" HALLIDAY MODEL H2W4848 DESIGNED FOR TRAFFIC LOADING.
6. NO VENTS ARE REQUIRED FOR THE PRV STATION.
7. TAPPING SADDLE & TAPPING METHOD SHALL BE JCM OR APPROVED EQUAL.

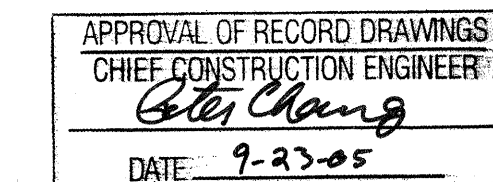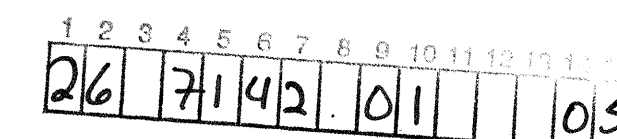[illegible]

1.....PIPING PLAN & CONNECTION DETAIL
2.....WATER SHUT-OFF PLAN



Gonnett Fleming West, Inc.
ENGINEERS AND PLANNERS


 CITY OF ALBUQUERQUE
 PUBLIC WORKS DEPARTMENT
 ENGINEERING DEVELOPMENT GROUP

TITLE: PARSIFAL PRESSURE REDUCING STATION RELOCATION
PIPING PLAN & CONNECTION DETAILS

Design Review Committee	City Engineer Approval	Last Design Update	Mo./Day/Yr.	Mo./Day/Yr.			
City Project No.	714201	Zone Map No.	H-20-Z	Sheet	1	Of	2

BENCH MARKS

KEY INFORMATION

ENGINEER'S SEAL




DATE	REMARKS
REVISIONS	
GANNETT FLEMING WEST, INC.	

DESIGNED BY	DDJ/JMG	DATE	6/17/04
-------------	---------	------	---------

Date: Jun 10, 2009 - 9:15am
Drawing Name: K:\PROJECTS\42985\015 PRV Relocation\015K01.dwg (For Internal Use Only)

SCANNED BY
WESA REPRO

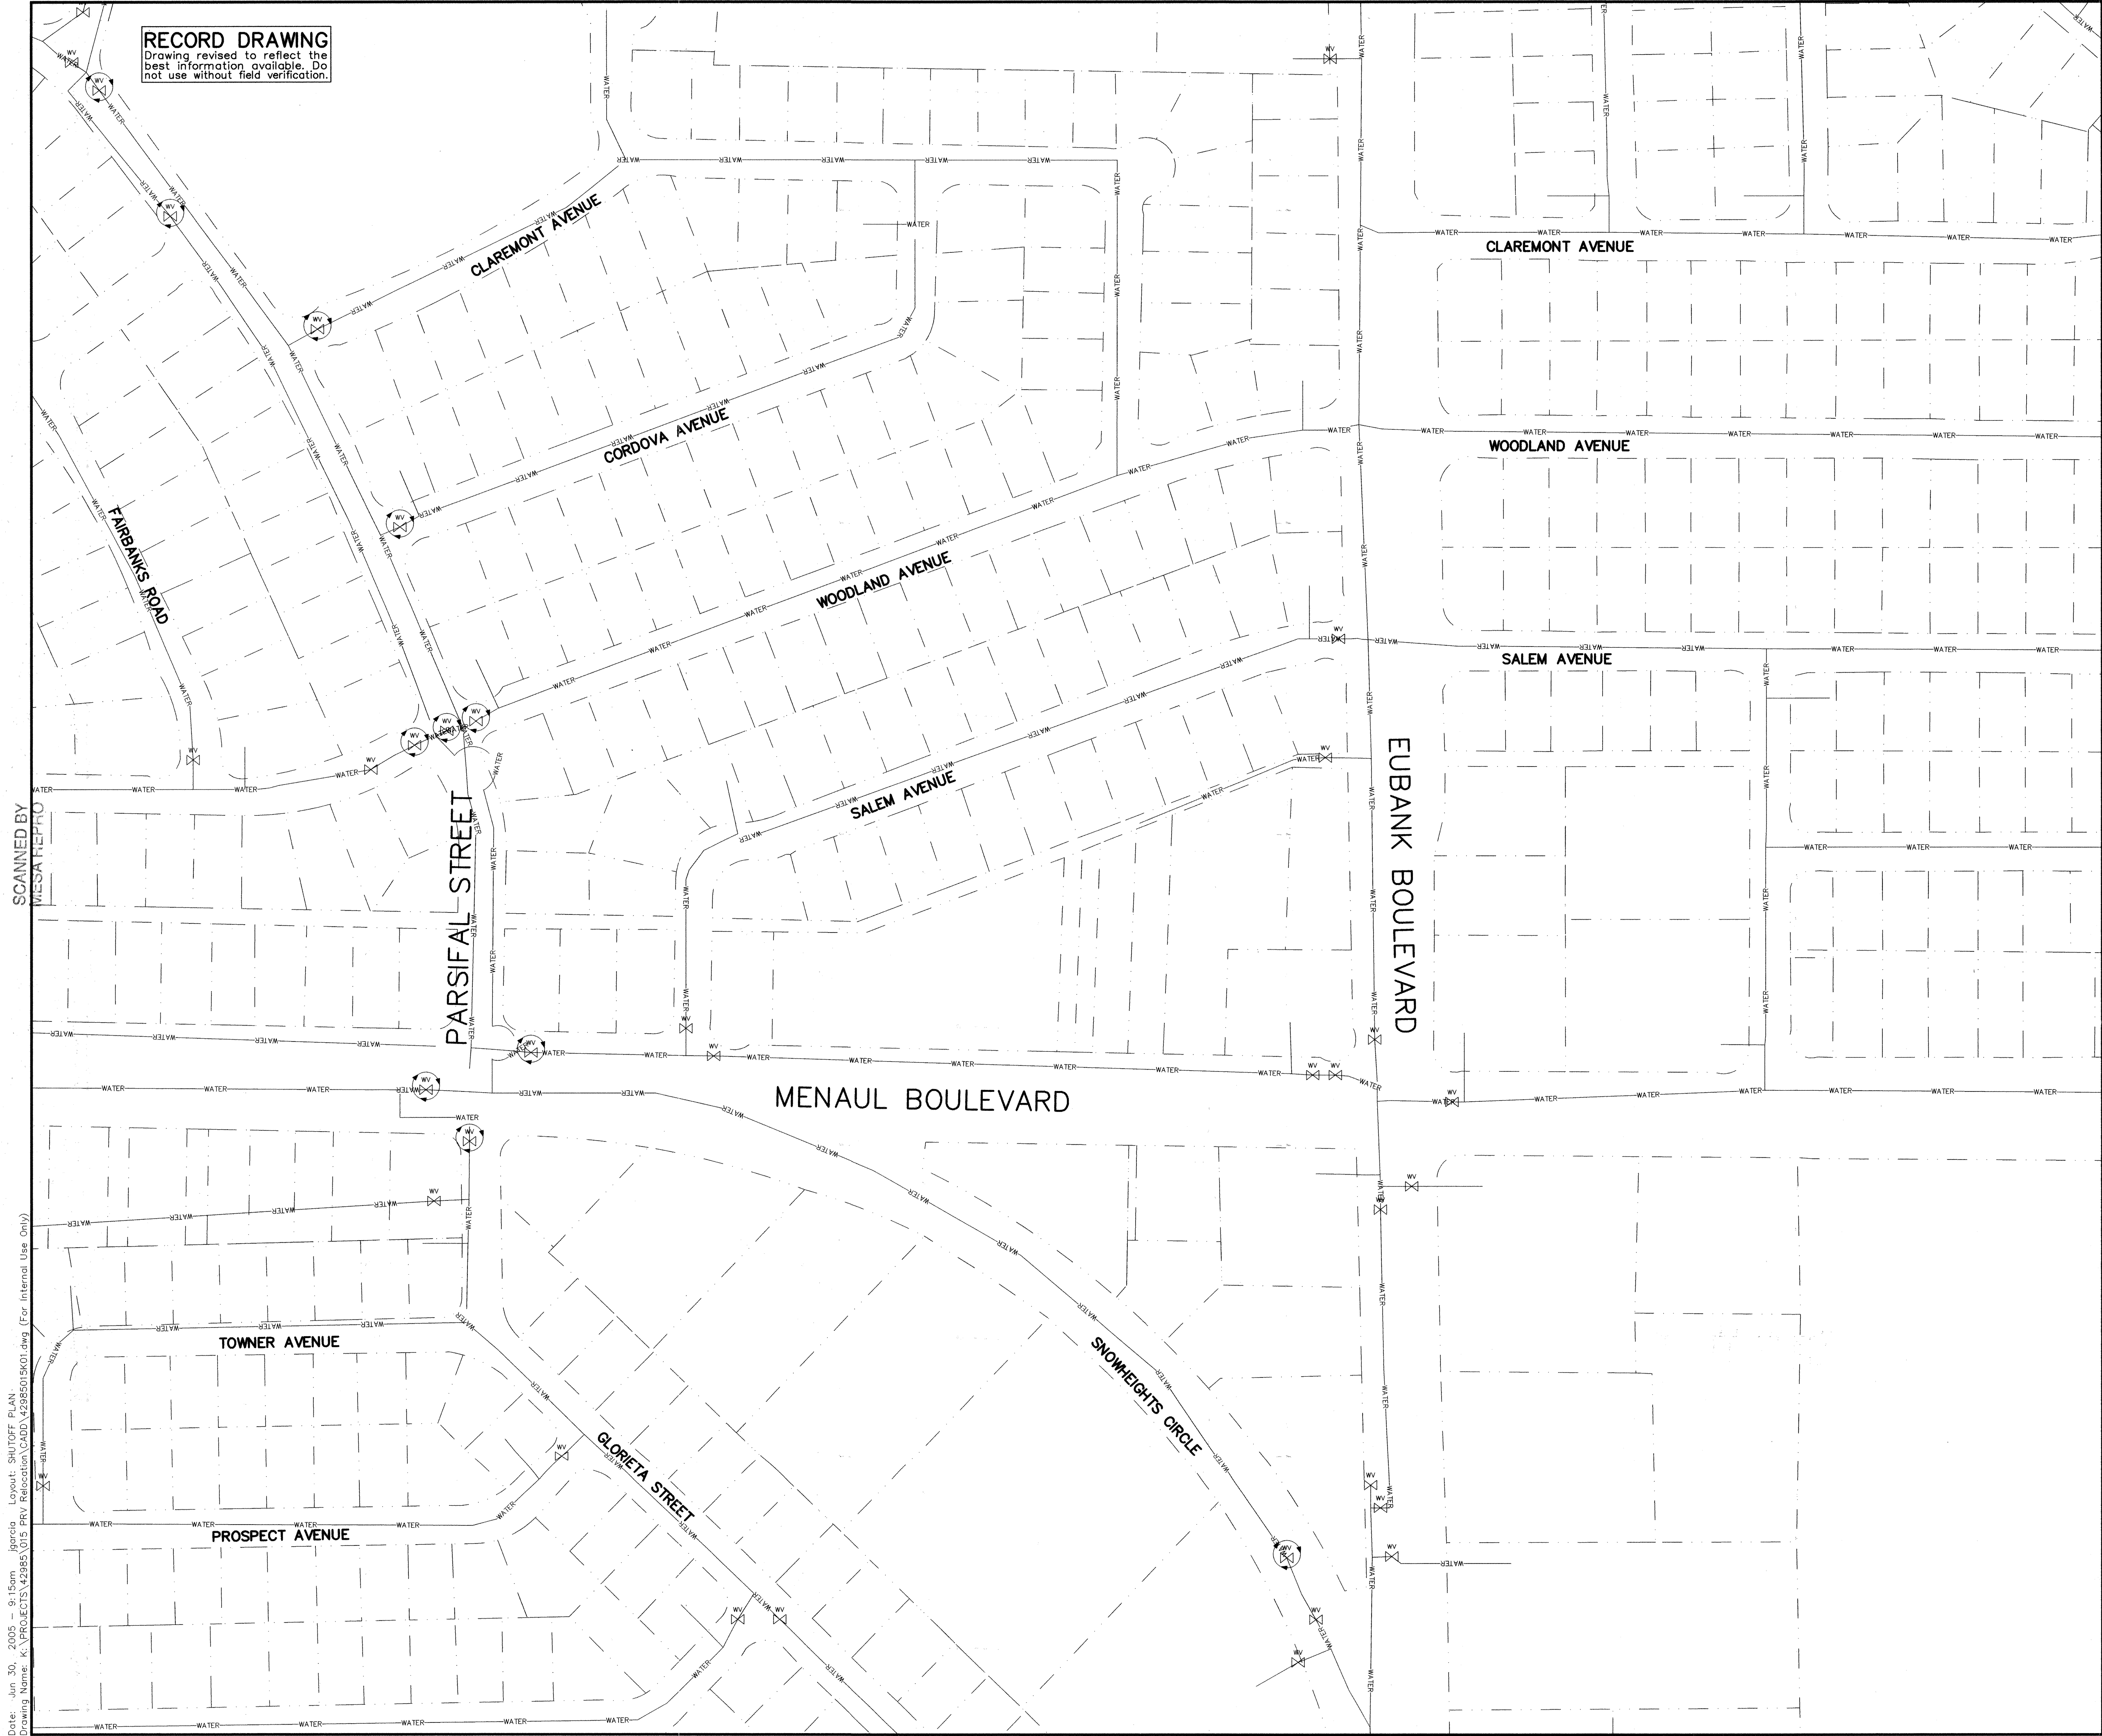


RECORD DRAWING
Drawing revised to reflect the
best information available. Do
not use without field verification.

LEGEND

- WV EXISTING WATER VALVE
WV EXISTING WATER VALVE TO BE
SHUTOFF DURING CONSTRUCTION

NOTES

1. THE LOCATION OF THE VALVES SHOWN ON
THIS SHUTOFF PLAN ARE APPROXIMATE AND
ARE NOT EXHAUSTIVE. THE CONTRACTOR
SHALL COORDINATE WITH THE CITY OF
ALBUQUERQUE WATER SYSTEMS DIVISION
FOR ASSISTANCE IN ISOLATING THE LINE
TO BE CONSTRUCTED

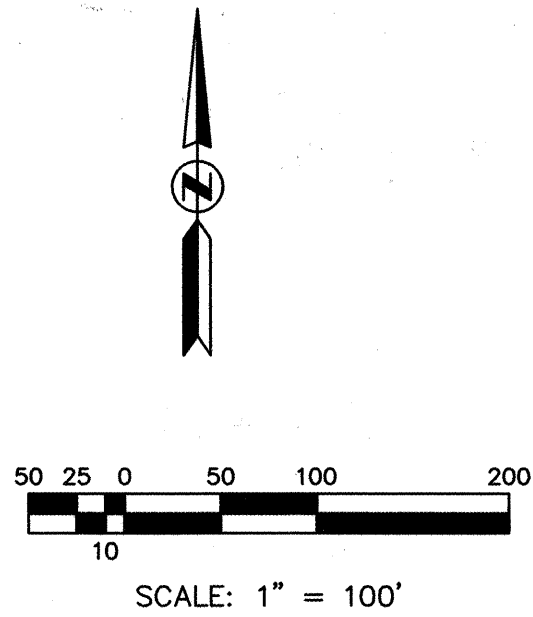


Gannett Fleming West, Inc.
ENGINEERS AND PLANNERS

CITY OF ALBUQUERQUE
PUBLIC WORKS DEPARTMENT
ENGINEERING DEVELOPMENT GROUP

**TITLE: PARSIFAL PRESSURE REDUCING STATION RELOCATION
WATER SHUT-OFF PLAN**

Design Review Committee	City Engineer Approval	Mo./Day/Yr.	Mo./Day/Yr.
City Project No.	Zone Map No.	Sheet	Of
714201	H-20-Z	2	2

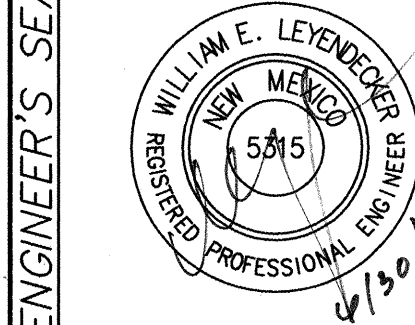

NO. DATE	REVISIONS	BY
1 6/05	AS-BUILT REVISIONS	
GANNETT FLEMING WEST, INC.		
DESIGNED BY	DD/JMG	DATE 6/17/04
DRAWN BY	JMG	DATE 10/14/04
CHECKED BY	WEL	DATE 6/17/04

NO.	BY	DATE

BENCH MARKS		

AS BUILT INFORMATION		
CONTRACTOR	J.R. HALE	DATE 2/05
INSPECTOR	R. DURAN	DATE 2/05
FIELD	D. JARAMILLO	DATE 2/05
VERIFICATION BY	GANNETT FLEMING	DATE 6/05
CORRECTED BY	WEST	DATE 6/05
MICRO-FILM INFORMATION		
RECORDED BY		DATE