




Albuquerque Bernalillo County Water Utility Authority



DURANES WELLS 2, 3 AND 6 WASHLINE MODIFICATIONS

RECORD DRAWINGS


Revisions Drawn by EJA Date 07/2007
THESE RECORD DRAWINGS HAVE BEEN PREPARED, IN PART, ON THE BASIS OF INFORMATION COMPILED BY OTHERS. THEY ARE NOT INTENDED TO REPRESENT IN DETAIL THE EXACT LOCATION, TYPE OF COMPONENT NOR MANNER OF CONSTRUCTION. THE ENGINEER WILL NOT BE RESPONSIBLE FOR ANY ERRORS OR OMISSIONS WHICH HAVE BEEN INCORPORATED INTO THE RECORD DRAWINGS.

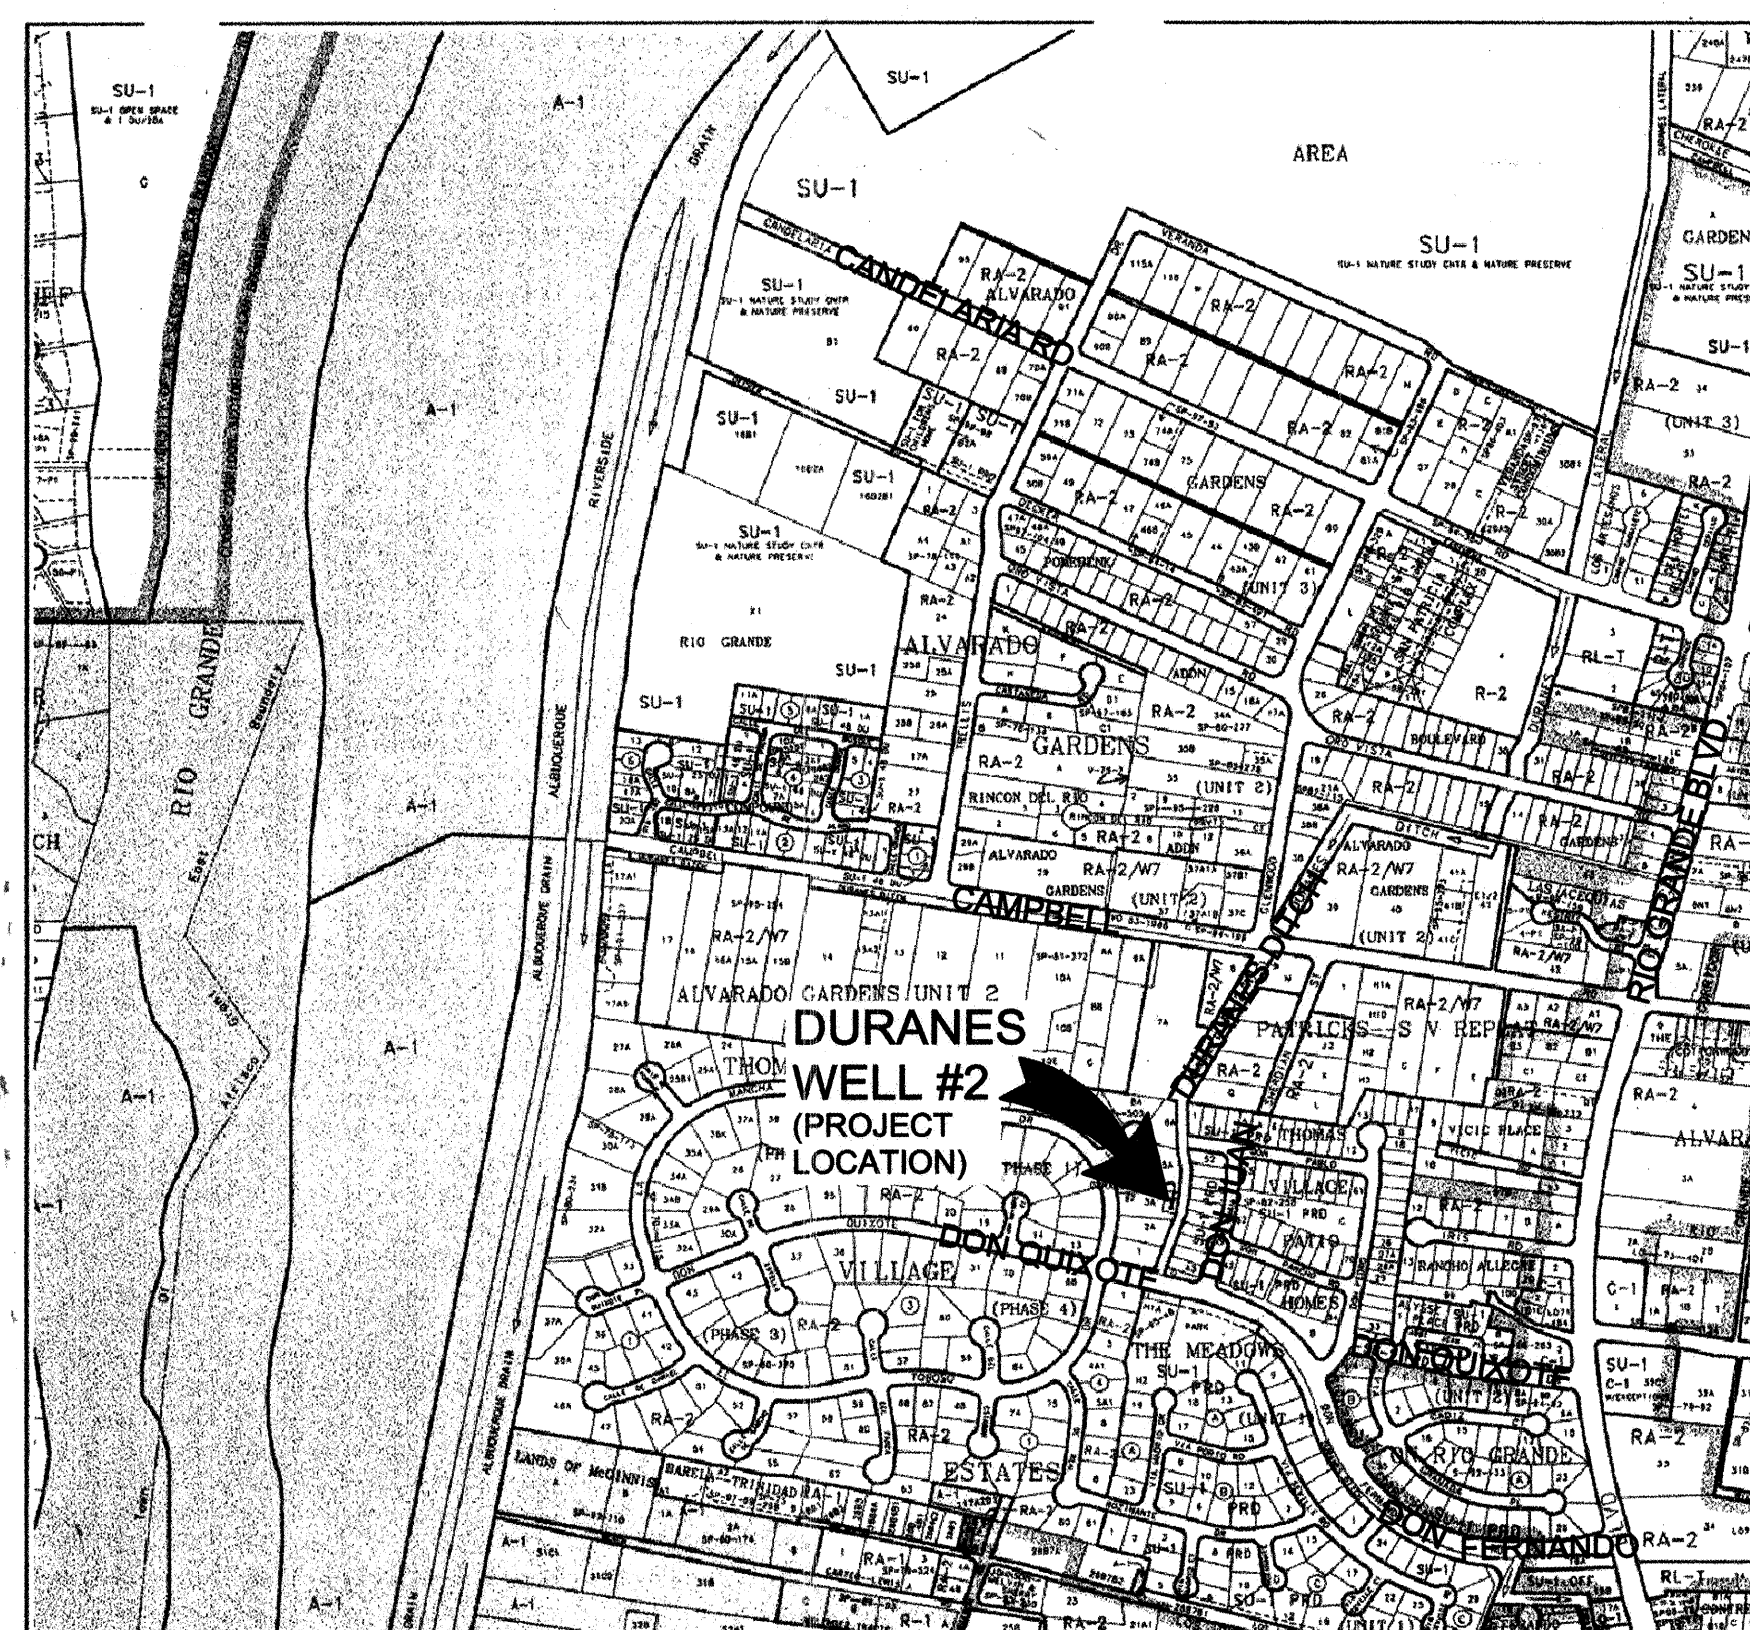

VICINITY MAP

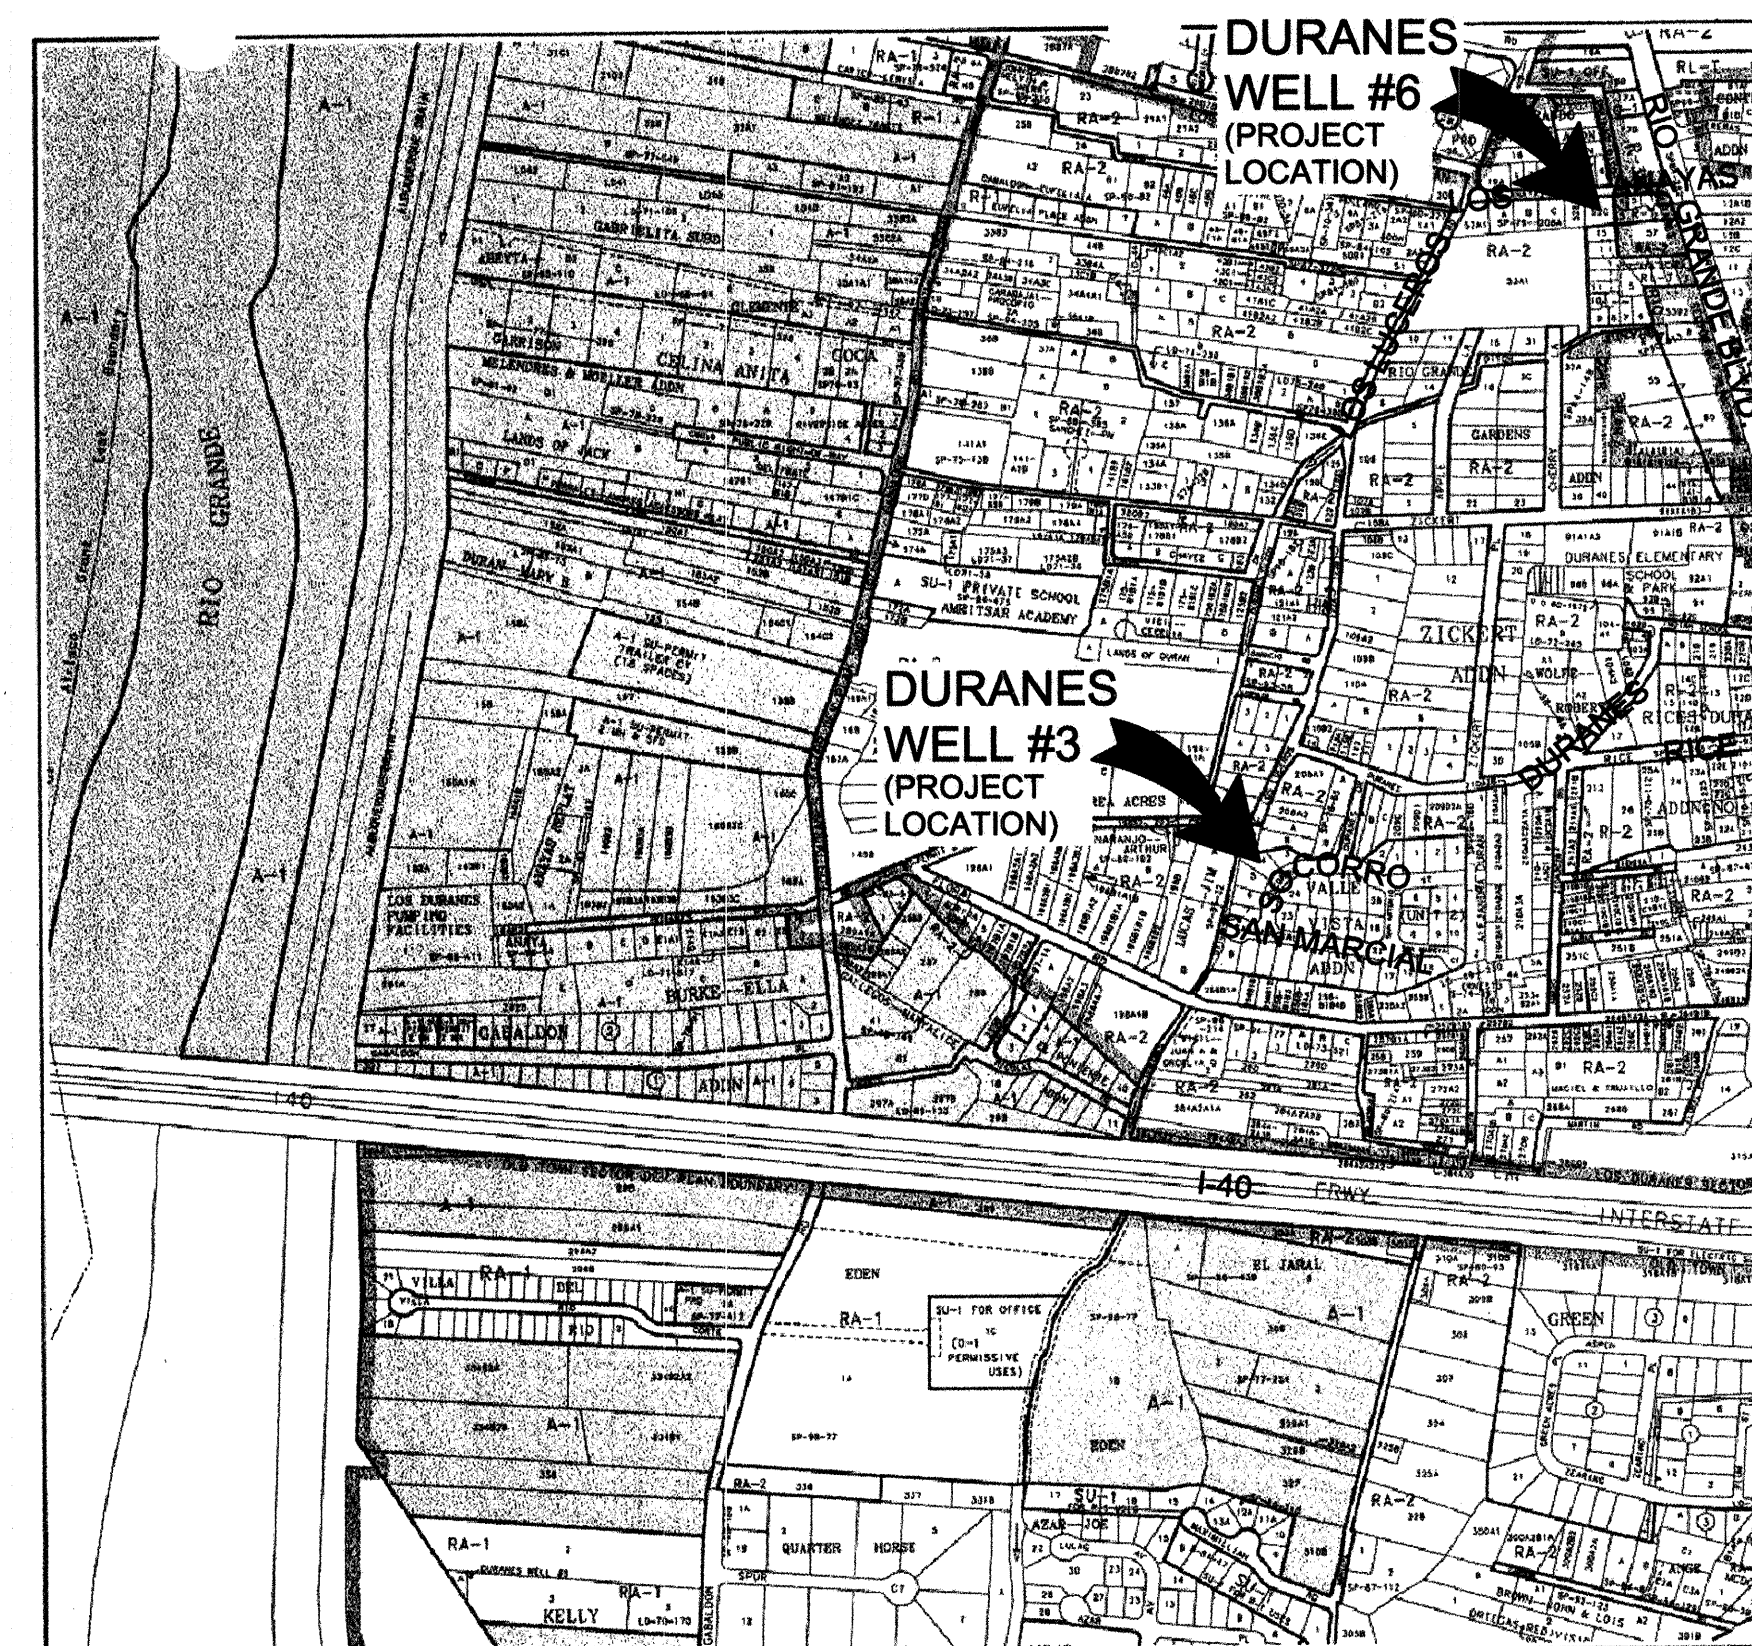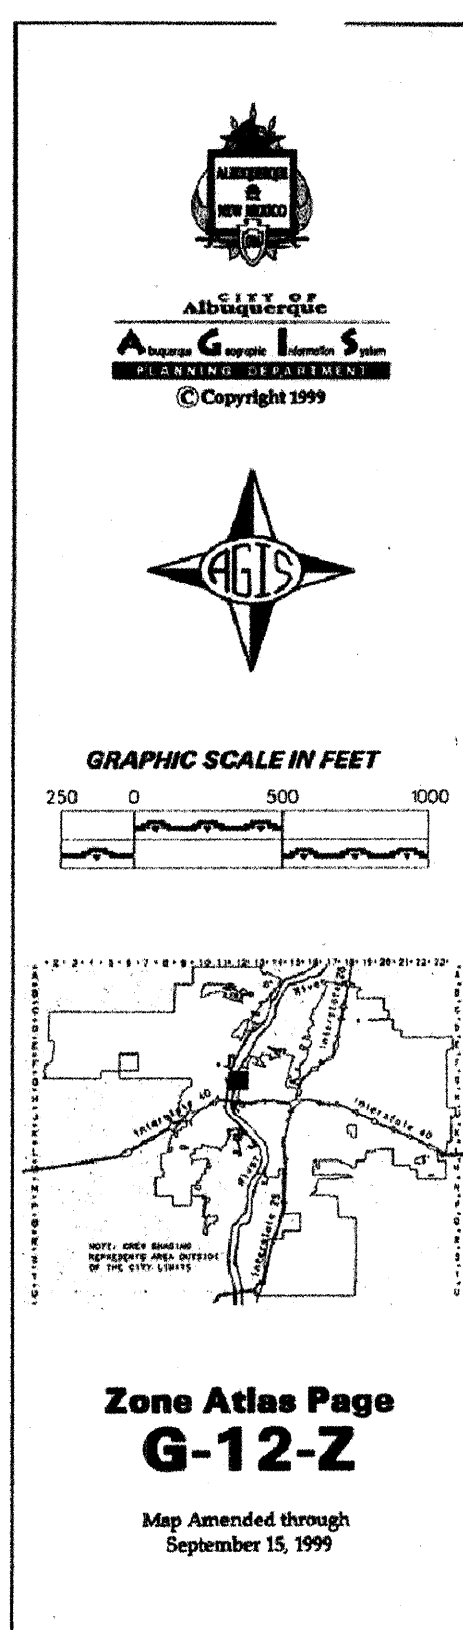

VICINITY MAP

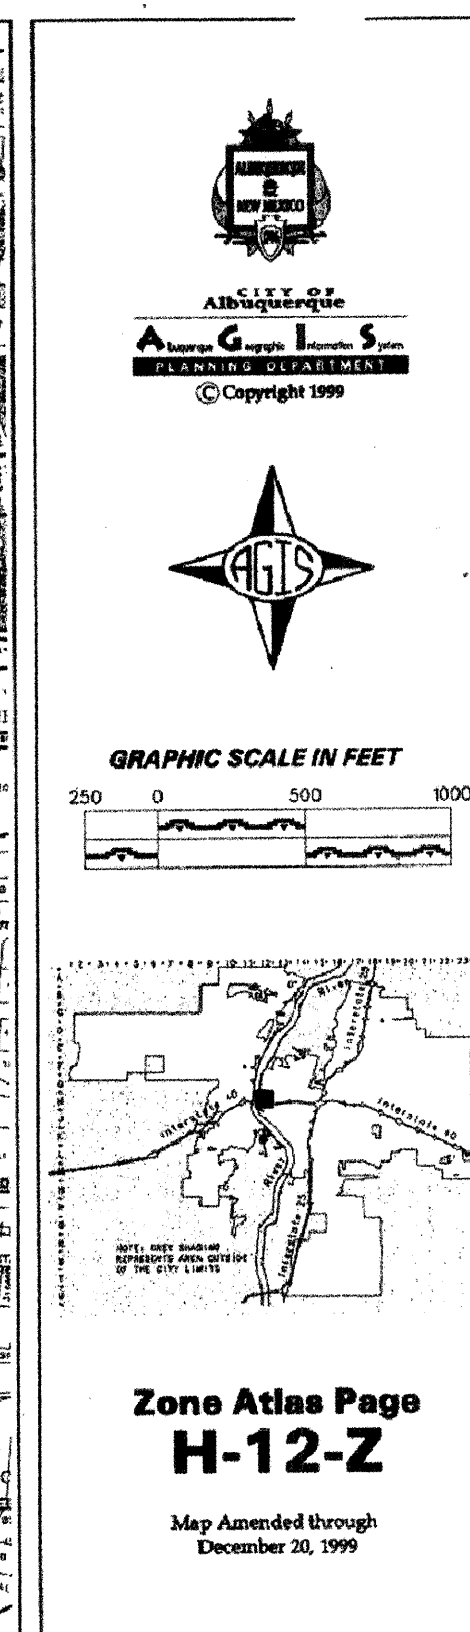

APPROVAL OF RECORD DRAWINGS	
PROJECT ENGINEER	<u>James Hill</u>
DATE	<u>Aug - 14 - 2007</u>

UTILITY CONTACTS

CITY OF ALBUQUERQUE
NANCY MUSINSKI
SENIOR ENGINEER, UTILITIES DIVISION
PHONE: (505) 768-2729
FAX: (505) 768-3629
EMAIL: NMUSINSKI@CABQ.GOV

COMCAST
RITA ERICKSON
PHONE: (505) 761-6235
FAX: (505) 761-0599
EMAIL: RITA_ERICKSON@CABLE.COMCAST.COM

PNM (ELECTRIC)
JIM HILL
PHONE: (505) 241-3581
FAX: (505) 241-0559
EMAIL: JHILL@PNM.COM

PNM (GAS)
JOE DUNLOP
PHONE: (505) 241-7771
FAX: (505) 241-7740
EMAIL: JDUNLOP@PNM.COM

QWEST
MICHAEL D. VELARDE
PHONE: (505) 245-8352
FAX: (505) 245-6733
EMAIL: MICHAEL.VELARDE@QWEST.COM

TIME WARNER TELECOM
ROYAL HARRISON
PHONE: (505) 938-7339
FAX: (505) 938-7380
EMAIL: ROYAL.HARRISON@TWTELECOM.COM

INDEX OF DRAWINGS

SHEET NO.	DRAWING NO.	TITLE OF SHEET
1	0-G-1	COVER / INDEX SHEET
2	0-G-2	GENERAL ABBREVIATIONS LEGENDS & NOTES
DURANES WELL #2		
3	1-C-1	DURANES WELL #2 SITE PIPING / DEMOLITION PLAN
4	1-PP-1	DURANES WELL #2 WASH LINE - STA. 17+40 TO STA. 19+67
5	1-PP-2	DURANES WELL #2 WASH LINE - STA. 15+00 TO STA. 17+40
6	1-PP-3	DURANES WELL #2 WASH LINE - STA. 12+50 TO STA. 15+00
7	1-PP-4	DURANES WELL #2 WASH LINE - STA. 11+00 TO STA. 12+50
8	1-PP-5	DURANES WELL #2 WASH LINE - STA. 9+50 TO STA. 11+00
DURANES WELL #3		
9	2-C-1	DURANES WELL #3 SITE PIPING / DEMOLITION PLAN
10	2-PP-1	DURANES WELL #3 WASH LINE - STA. 14+40 TO STA. 16+63
11	2-PP-2	DURANES WELL #3 WASH LINE - STA. 12+40 TO STA. 14+40
12	2-PP-3	DURANES WELL #3 WASH LINE - STA. 10+40 TO STA. 12+40
13	2-PP-4	DURANES WELL #3 WASH LINE - STA. 9+50 TO STA. 10+40
DURANES WELL #6		
14	3-C-1	DURANES WELL #6 SITE PIPING / DEMOLITION PLAN
DETAIL SHEETS		
15	4-M-1	MISCELLANEOUS DETAILS - AIR GAP CHAMBER
16	4-M-2	MISCELLANEOUS DETAILS - TRENCH SECTIONS

CH2MHILL

6001 Indian School Rd, N.E., SUITE 350
Albuquerque, New Mexico 87110
(505) 884-5600

REV	SHEETS	CITY ENGINEER	DATE	USER DEPARTMENT	DATE	USER DEPARTMENT	DATE
ENGINEERS STAMP & SIGNATURE		APPROVALS		ENGINEER	DATE	*****	
		DRC Chairman		<u>James Hill</u>	<u>9-26-06</u>	APPROVED FOR CONSTRUCTION	
		Transportation		<u>William J. Dabbs</u>	<u>9-26-06</u>		
		Water/Wastewater		<u>William J. Dabbs</u>	<u>9-26-06</u>		
		Hydrology		<u>William J. Dabbs</u>	<u>9-26-06</u>		
		Water Resources		<u>William J. Dabbs</u>	<u>9-26-06</u>		
Const.Coord.		<u>James Hill</u>	<u>9-26-06</u>	City Engineer		Date	
Water Utility Div.		<u>James Hill</u>	<u>9-26-06</u>	City Project No.		7279-03	
						Sheet 1 of 16	
						DRAWING NO. 0-G-1	









ABBREVIATIONS

AB	ANCHOR BOLT	M-4	MECHANICAL DRAWING 4TH SHEET
AFF	ABOVE FINISH FLOOR	MAX	MAXIMUM
AL	ALUMINUM	MB	MACHINE BOLT
ALTN	ALTERNATE	MECH	MECHANICAL
APPROX	APPROXIMATELY	MH	MANHOLE
ARCH	ARCHITECTURAL	MJ	MECHANICAL JOINT
BFV	BUTTERFLY VALVE	MIN	MINIMUM
BLDG	BUILDING	NTS	NUMBER
BOF	BOTTOM OF FOOTING	NO	NOT TO SCALE
BOT	BOTTOM	OC	ON CENTER
BF	BOTTOM FACE	OD	OUTSIDE DIAMETER, OVERFLOW DRAIN
BM	BEAM, BENCHMARK	OF	OUTSIDE FACE
BRG	BEARING	PC	POINT OF CURVATURE
C-2	CIVIL DRAWING 2ND SHEET	PE	PLAIN END
CCP	CONCRETE CYLINDER PIPE	PI	POINT OF INTERSECTION
CI	CAST IRON	PL, $\varnothing$	PLATE
CJ	CONSTRUCTION JOINT	PP	POWER POLE
C, CL	CENTER LINE	PP-2	PLAN AND PROFILE DRAWING 2nd SHEET
CLR	CLEAR, CLEARANCE	PSI	POUNDS PER SQUARE INCH
CONC	CONCRETE	PT	POINT OF TANGENT
CONT	CONTINUOUS	PVC	POLYVINYL CHLORIDE
CPLG	COUPLING	RCP	REINFORCED CONCRETE PIPE
CTR	CENTER	RDCR	REDUCER
CTRD	CENTERED	REINF	REINFORCED
DI OR DIP	DUCTILE IRON PIPE	REQ'D	REQUIRED
DIA	DIAMETER	RT	RIGHT
DWG	DRAWING	R/W, R.O.W.	RIGHT-OF-WAY
EF	EACH FACE	SAS	SANITARY SEWER
EL OR ELEV	ELEVATION	S-3	STRUCTURAL DRAWING 3RD SHEET
EQ	EQUAL	SCHD	SCHEDULE
EW	EACH WAY	SD	STORM DRAIN/SEWER
EWEF	EACH WAY EACH FACE	SHT	SHEET
EXIST, EXST, EXTG	EXISTING	SIM	SIMILAR
FF	FINISH FLOOR	SPA	SPACING
FG	FINISHED GRADE	SS	SQUARE
FH	FIRE HYDRANT	SS OR SST	STAINLESS STEEL
FL, $\varnothing$	FLOW LINE	STA	STATION
FLG	FLANGE	STD	STANDARD
FT	FOOT (FEET)	TBM	TEMPORARY BENCH MARK
G-1	GENERAL DRAWING 1ST SHEET	T&B	TOP AND BOTTOM
GA	GAUGE	TC	TOP OF CURB/CONCRETE
GALV	GALVANIZED (HOT DIP)	TF	TOP FACE
GV	GATE VALVE	TG	TOP OF GRADE
HORIZ	HORIZONTAL	T.O.P.	TOP OF PIPE
HT	HEIGHT	T.O.	TOP OF
ID	INSIDE DIAMETER	TYP	TYPICAL
IF	INSIDE FACE	VERT	VERTICAL
JT	JOINT	WM	WATER METER
LF	LINEAR FEET	WS	WELDED STEEL, WATERSTOP
LT	LEFT	WV	OR WATER SURFACE
			WATER VALVE

MIDDLE RIO GRANDE CONSERVANCY DISTRICT (M.R.G.C.D.)

GENERAL CONSTRUCTION NOTES:

      - ANY WORK TO BE PERFORMED WITHIN THE MIDDLE RIO GRANDE CONSERVANCY DISTRICT (M.R.G.C.D.) RIGHT-OF-WAY SHALL BE CLOSELY COORDINATED WITH THE M.R.G.C.D. ENGINEERING DEPARTMENT AND APPROPRIATE FIELD OFFICE. PHONE: (505) 247-0234.
- NO WORK IS TO BE DONE ON FACILITIES OR STRUCTUES BELONGING TO, OR OPERATED BY THE M.R.G.C.D. BETWEEN MARCH 1 AND OCTOBER 31 INCLUSIVE. HOWEVER, WORK MAY BE PERMITTED BY THE M.R.G.C.D. IF IT CAN BE SHOWN THAT THE WORK WILL NOT INTERFERE WITH OPERATIONS OF THE M.R.G.C.D. FACILITY. ALL WORK TO BE DONE WITHIN THE M.R.G.C.D. FACILITIES MUST BE APPROVED BY THE M.R.G.C.D. ENGINEERING PRIOR TO COMMENCING WORK.
- THE CONTRACTOR SHALL NOT STORE EQUIPMENT, NEW MATERIALS, OR DEBRIS WITHIN DISTRICT RIGHT-OF-WAY WHICH MAY INTERFERE WITH OPERATIONS AND MAINTENANCE OF THE M.R.G.C.D. FACILITY.
- THE CONTRACTOR SHALL NOT SERVICE VEHICLES OR EQUIPMENT WITHIN M.G.R.C.D. RIGHT-OF-WAY.
- SEEDING OF DISTURBED AREAS WITHIN M.G.R.C.D. RIGHT-OF-WAY IS REQUIRED PER THE M.G.R.C.D. SEEDING SPECIFICATIONS.
- THE CONTRACTOR MUST MAINTAIN A MINIMUM COVER OF 3' OVER ALL CULVERT CROSSINGS USED FOR ACCESS TO THE PROJECT SITE.
- THE CONTRACTOR IS RESPONSIBLE FOR REPAIRING AND OR REPLACEMENT OF ANY STRUCTURES REMOVED AND OR DAMAGED DUE TO THE CONTRACTORS ACTIVITIES WITHIN THE DISTRICTS RIGHT-OF-WAY. SHOULD ANY TURNOUTS, CULVERT PIPES AND OR STRUCTURES REQUIRE REPLACEMENT DUE TO LEAKAGE AND OR DAMAGE BY THE CONTRACTOR, NEW TURNOUTS, AND NEW CULVERT PIPES AND OR NEW STRUCTURES SHALL REPLACE THE DAMAGED ITEM. REPAIRS AND OR REPLACEMENTS WITHIN THE DISTRICTS RIGHT-OF-WAY MUST COMPLY WITH THE DISTRICTS SPECIFICATIONS.
- ALL DAMAGED CULVERT CROSSINGS AND CULVERT CROSSING REMOVED AND OR DISTURBED MUST BE RESTORED AND / OR REPLACED TO THE SATISFACTION OF THE M.R.G.C.D. AND COMPLY WITH M.R.G.C.D. SPECIFICATIONS.
- ALL SALVAGABLE CULVERTS, IRRIGATION GATES, ETC. MUST BE RETURNED TO THE M.R.G.C.D..
- THE CONTRACTOR IS RESPONSIBLE FOR EXECUTING A "SPECIAL USE LICENSE AGREEMENT" WITH THE M.R.G.C.D. PRIOR TO CONSTRUCTION.

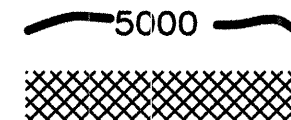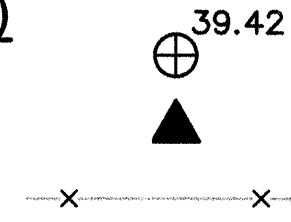

FINISH GRADE

TEMPORARY BENCH MARK

CHAIN LINK FENCE

EXISTING CONTOURS

PROPOSED CONTOURS

DEMOLITION (TO BE REMOVED)

DRAINAGE SWALE

PROPERTY LINE OR RIGHT-OF-WAY

PROPOSED PIPE

EXIST SANITARY SEWER

EXIST WATER LINE

EXIST GAS LINE

EXIST UNDERGROUND TELEPHONE

EXIST UNDERGROUND ELECTRIC

EXIST STORM SEWER

EXIST UNDERGROUND CABLE TELEVISION

EXIST FIBER OPTIC

TOP OF CURB/FLOW LINE

TOP OF WALL

TOP OF ASPHALT

CONCRETE/NATURAL GROUND



LIGHT POLE



GAS METER



WATER METER



EXISTING SANITARY MANHOLE



EXISTING STORM DRAIN MANHOLE



NEW MANHOLE



FIRE HYDRANT



POWER POLE



ANCHOR



TREE (EVERGREEN)



TREE (DECIDUOUS)



DROP INLET



OVERHEAD POWER LINE



PIPE SLOPE IN FT/FT



EDGE OF PAVEMENT





EXISTING WATER LINE VALVE (GATE VALVE OR BUTTERFLY VALVE)

RECORD DRAWINGS

Revisions Drawn by EJA Date 07/2007
THESE RECORD DRAWINGS HAVE BEEN PREPARED, IN PART, ON THE BASIS OF INFORMATION COMPILED BY OTHERS. THEY ARE NOT INTENDED TO REPRESENT IN DETAIL THE EXACT LOCATION, TYPE OF COMPONENT NOR MANNER OF CONSTRUCTION. THE ENGINEER WILL NOT BE RESPONSIBLE FOR ANY ERRORS OR OMISSIONS WHICH HAVE BEEN INCORPORATED INTO THE RECORD DRAWINGS.

GENERAL CONSTRUCTION NOTES:

- CITY OF ALBUQUERQUE SPECIFICATIONS FOR PUBLIC WORKS CONSTRUCTION, 1986 EDITION AS AMENDED THROUGH UPDATE NO. 7 DATED JULY 2003 AND AMENDMENT No.1 DATED AUGUST 2005, WILL BE REFERRED TO HEREIN AS THE "STANDARD SPECIFICATIONS".
- REFERENCES MADE HEREIN TO CITY STD DWG REFER TO THE CURRENT STANDARD DETAIL DRAWINGS, AS SHOWN IN THE CITY OF ALBUQUERQUE STANDARD SPECIFICATIONS FOR PUBLIC WORKS CONSTRUCTION, 1986, AS AMENDED THROUGH UPDATE NO. 7, DATED JULY 2003 AND AMENDMENT No. 1 DATED AUGUST 2005.
- HORIZONTAL AND VERTICAL LOCATION, DIAMETER, AND MATERIAL OF EXISTING PIPING AND UTILITIES ARE APPROXIMATE AND SHALL BE VERIFIED BY CONTRACTOR.
- CONTRACTOR SHALL MAKE NECESSARY PROVISIONS FOR THE DISPOSAL OF WATER TO BE DRAINED FROM EXISTING WATERLINES. CONTRACTOR SHALL PROVIDE SANITARY, TEMPORARY CAP ON EXISTING PIPELINES UNTIL READY TO MAKE FINAL CONNECTION. PRIOR TO THE START OF WORK THE CONTRACTOR SHALL SUBMIT PROPOSED METHODS AND PROCEDURES FOR DRAINING OF PIPELINES, INCLUDING DISPOSAL LOCATIONS, TO THE ENGINEER AND OWNER FOR REVIEW AND APPROVAL.
- CONTRACTOR SHALL ENSURE THAT NO SOIL ERODES FROM THE SITE INTO PUBLIC RIGHT-OF-WAY OR ONTO PRIVATE PROPERTY. THIS SHALL BE ACHIEVED BY CONSTRUCTION OF TEMPORARY BERMS AT PROPERTY LINES AND/OR WETTING SOIL TO KEEP IT FROM BLOWING.
- THE CONTRACTOR SHALL PROMPTLY CLEAN UP AND REMOVE FROM THE SITE ALL EXCAVATED MATERIAL SO THAT THE EXCAVATED MATERIAL IS NOT SUSCEPTIBLE TO BEING WASHED AWAY OR CREATE BLOWING DUST.
- CONTRACTOR SHALL MAINTAIN DUST CONTROL AT ALL TIMES. PRIOR TO THE START OF WORK THE CONTRACTOR SHALL OBTAIN A TOPSOIL DISTURBANCE PERMIT FROM THE ENVIRONMENTAL HEALTH DEPARTMENT, AIR POLLUTION CONTROL DIVISION.
- FIVE (5) WORKING DAYS PRIOR TO BEGINNING CONSTRUCTION THE CONTRACTOR SHALL SUBMIT TO THE CONSTRUCTION COORDINATION DIVISION, A DETAILED CONSTRUCTION SCHEDULE. TWO (2) WORKING DAYS PRIOR TO CONSTRUCTION, THE CONTRACTOR SHALL OBTAIN A BARRICADING PERMIT FROM THE CONSTRUCTION COORDINATION DIVISION. CONTRACTOR SHALL NOTIFY THE BARRICADE ENGINEER (924-3400) PRIOR TO OCCUPYING AN INTERSECTION OR RIGHT-OF- WAY. SEE SECTION 19 OF THE STANDARD SPECIFICATIONS.
- PERMANENT PAVEMENT STRIPING AND MARKINGS WILL BE PLACED BY THE CONTRACTOR. THE ROAD SHALL NOT BE OPENED TO TRAFFIC UNTILL IT IS STRIPED. ALL STRIPING, PAVEMENT MARKINGS INCLUDING CROSSWALKS, ARROWS AND LINE MARKINGS ARE TO BE CONSTRUCTED OF HOT PLASTIC OR COLD PLASTIC IN ACCORDANCE WITH THE MANUAL OF UNIFORM TRAFFIC CONTROL DEVICES.
- CONTRACTOR SHALL REPLACE AND/OR RESTORE ALL PAVEMENT, CURBS, SIDEWALK, ROCK SURFACING, LANDSCAPING, AND OTHER SITE FIXTURES DAMAGED DIRECTLY OR INDIRECTLY BY CONTRACTOR TO SAME LOCATION AND IN KIND AS EXISTING OR AS SHOWN IN THIS PLANSET.
- PRIOR TO ANY CONSTRUCTION, THE CONTRACTOR SHALL EXCAVATE AND VERIFY THE HORIZONTAL AND VERTICAL LOCATIONS OF ALL OBSTRUCTIONS. SHOULD A CONFLICT EXIST, THE CONTRACTOR SHALL NOTIFY THE ENGINEER OR OWNER SO THAT THE CONFLICT CAN BE RESOLVED WITH A MINIMUM AMOUNT OF DELAY.
- TWO (2) WORKING DAYS PRIOR TO ANY EXCAVATION, CONTRACTOR SHALL CONTACT THE NEW MEXICO ONE CALL SYSTEM (260-1990) AND DETERMINE LOCATION OF EXISTING UTILITIES.
- CONTRACTOR SHALL NOT OPERATE VALVES OR ISOLATE ANY PORTION OF THE WATER DISTRIBUTION, COLLECTOR, OR TRANSMISSION SYSTEM. SEVEN (7) WORKING DAYS PRIOR TO ANY WORK ON THE EXISTING PUBLIC WATER UTILITIES, THE CONTRACTOR SHALL CONTACT THE WATER UTILITY DIVISION AND SUBMIT A PERMIT FOR A WATER SHUT-OFF OR TURN-ON. SEE SECTION 18 OF THE "STANDARD SPECIFICATIONS".
- ALL UTILITIES SHOWN AND ANY OTHER UTILITIES THAT ARE NOT SHOWN ON THE PLANS BUT ARE WITHIN THE CONSTRUCTION AREA SHALL BE LOCATED, IDENTIFIED, AND PROTECTED AT ALL TIMES DURING CONSTRUCTION BY THE CONTRACTOR. SERVICE LATERALS ARE NOT SHOWN. CONTRACTOR SHALL BE RESPONSIBLE FOR PROTECTION OF ALL LATERALS AND SHALL REINSTALL, REPAIR, OR REPLACE LATERALS AS NECESSARY FOR PIPELINE INSTALLATION. REPLACEMENT OF ALL SERVICE LATERALS REQUIRED FOR THIS CONSTRUCTION SHALL BE IN ACCORDANCE WITH THE "STANDARD SPECIFICATIONS".
- THE CONTRACTOR SHALL NOTIFY THE ENGINEER NOT LESS THAN SEVEN (7) DAYS PRIOR TO STARTING WORK IN ORDER THAT THE ENGINEER MAY TAKE NECESSARY MEASURES TO INSURE THE PRESERVATION OF SURVEY MONUMENTS. CONTRACTOR SHALL NOT DISTURB PERMANENT SURVEY MONUMENTS WITHOUT THE CONSENT OF THE ENGINEER AND SHALL NOTIFY THE ENGINEER AND BEAR THE EXPENSE OF REPLACING ANY THAT MAY BE DISTURBED WITHOUT PERMISSION. REPLACEMENT SHALL BE DONE ONLY BY THE CITY SURVEYOR. WHEN A CHANGE IS MADE IN THE FINISHED ELEVATIONS OF THE PAVEMENT OF ANY ROADWAY IN WHICH A PERMANENT SURVEY MONUMENT IS LOCATED, THE CONTRACTOR SHALL, AT HIS OWN EXPENSE, ADJUST THE MONUMENT COVER TO THE NEW GRADE UNLESS OTHERWISE SPECIFIED. REFER TO SECTION 4.4 OF THE GENERAL CONDITIONS OF THE STANDARD SPECIFICATIONS.
- THE CONTRACTOR SHALL MAINTAIN A GRAFFITI-FREE WORK SITE. CONTRACTOR SHALL PROMPTLY REMOVE ANY AND ALL GRAFFITI FROM EQUIPMENT, WHETHER PERMANENT OR TEMPORARY.
- CONTRACTOR SHALL PROVIDE AND INSTALL SHEETING, SHORING, TRENCH BOX, OR OTHER MEANS NECESSARY TO LIMIT THE TRENCH WIDTH TO WITHIN THE LIMITS SHOWN ON THE PLANS.
- CONTRACTOR SHALL BE RESPONSIBLE FOR INITIATING, MAINTAINING, AND SUPERVISING ALL SAFETY PRECAUTIONS AND PROGRAMS IN CONNECTION WITH THE WORK TO CONSTRUCT THE FACILITIES SHOWN ON THE DRAWINGS. ALL TRENCHING, EXCAVATION, AND SHORING ACTIVITIES SHALL BE CARRIED OUT IN ACCORDANCE WITH OSHA 29 CFR 1926.650 SUBPART P.
- FOR STORM DRAIN CONSTRUCTION, RCP PIPE JOINTS SHALL NOT BE GROUTED PRIOR TO FINAL INSPECTION. FINAL INSPECTION WILL DETERMINE JOINTS TO BE GROUTED FOR FINAL ACCEPTANCE OF THE CONSTRUCTION.
- ELECTRONIC MARKER DISKS (EMD) WILL BE PLACED ACCORDING TO SECTION 170 OF THE CITY OF ALBUQUERQUE STANDARD SPECIFICATIONS FOR PUBLIC WORKS CONSTRUCTION, 1986 EDITION AS REVISED THROUGH UPDATE #7.
- THE CONTRACTOR WILL BE RESPONSIBLE FOR DISPOSING OF ALL DEBRIS, INCLUDING, NOT LIMITED TO HAZARDOUS WASTE AT DISPOSAL SITES APPROVED BY GOVERNMENTAL AGENCIES REGULATING THE DISPOSAL OF SUCH MATERIALS.
- ALL WATER VALVE BOXES AND MANHOLES IN THE STREET CONSTRUCTION ARE TO BE ADJUSTED TO FINISH GRADE AND WILL BE MEASURED AND PAID PER EACH.
- CONTRACTOR WILL BE RESPONSIBLE FOR PROVIDING AND MAINTAINING ALL CONSTRUCTION SIGNING UNTIL PROJECT HAS BEEN ACCEPED BY THE CITY.

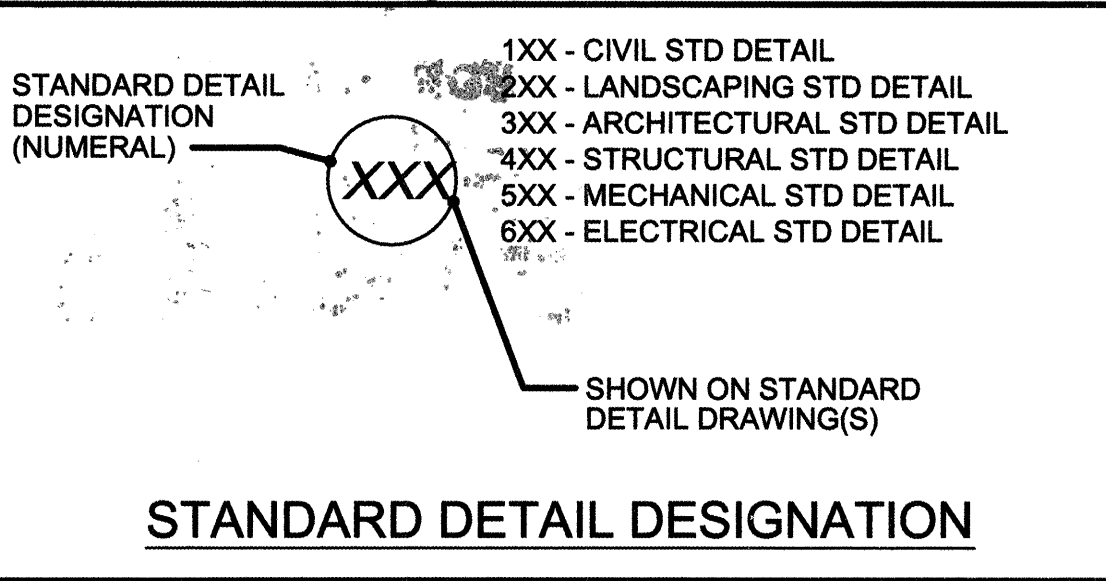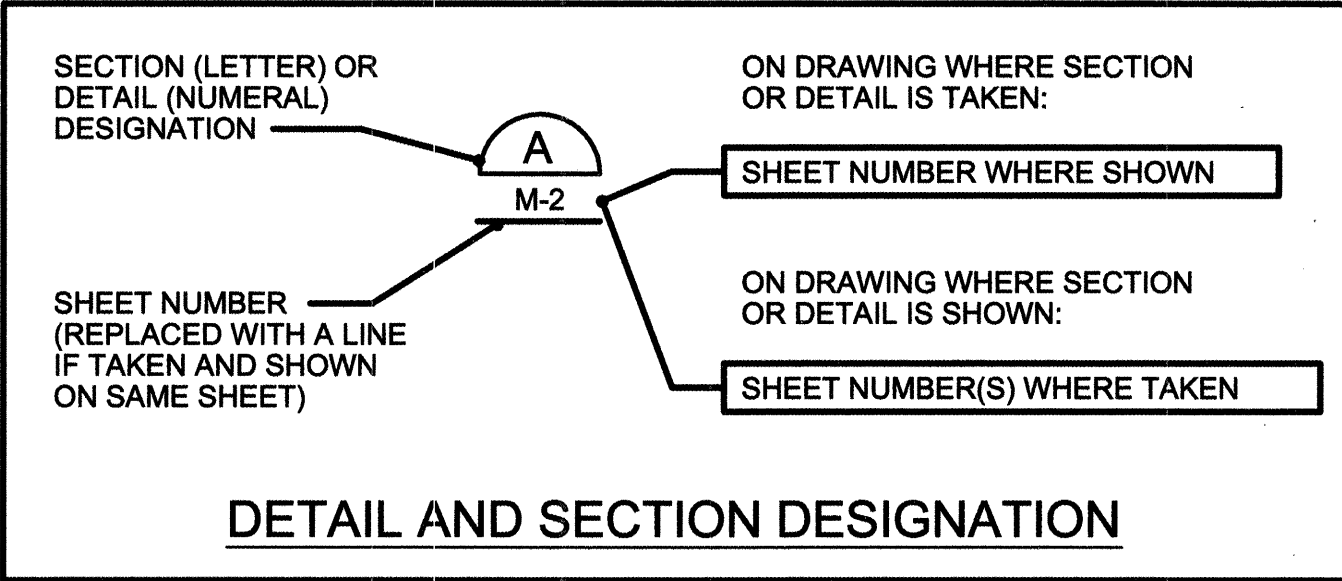

CENTERLINE OF SURVEY NOTES:

- ALL BEARINGS AND DISTANCES SHOWN ON THE DRAWINGS ARE BASED ON NEW MEXICO STATE PLANE COORDINATE SYSTEM CENTRAL ZONE:
HORIZONTAL DATUM: NAD 27
VERTICAL DATUM: SLD 29
GROUND TO GRID SCALE FACTOR: 0.9996813
- CENTERLINE SURVEY BEARINGS AND DISTANCES SHOWN ON THE DRAWINGS ARE MEASURED FROM POINT OF INTERSECTION TO POINT OF INTERSECTION.

VERIFY SCALES
BAR IS ONE INCH ON ORIGINAL DRAWING
IF NOT ONE INCH ON THIS SHEET, ADJUST SCALES ACCORDINGLY.

CH2MHILL

6001 Indian School Rd, N.E., SUITE 350
Albuquerque, New Mexico 87110
(505) 884-5600



Albuquerque Bernalillo County
Water Utility Authority

TITLE: DURANES WELLS 2, 3 AND 6 WASHLINE MODIFICATIONS
GENERAL ABBREVIATIONS LEGEND & NOTES

Design Review Committee
APPROVE
SEP 2 6 2006
DESIGN REVIEW COMMITTEE



City Engineer Approval
APPROVE
SEP 2 6 2006
CITY ENGINEER

Last Design Update
Mo./Day/Yr. Mo./Day/Yr.
DESIGNED BY EKH
DRAWN BY EJA
CHECKED BY MAB

CITY PROJECT NO.

7279-03

Zone Map No. SHEET 2 OF 16
DRAWING NO. 0-G-2

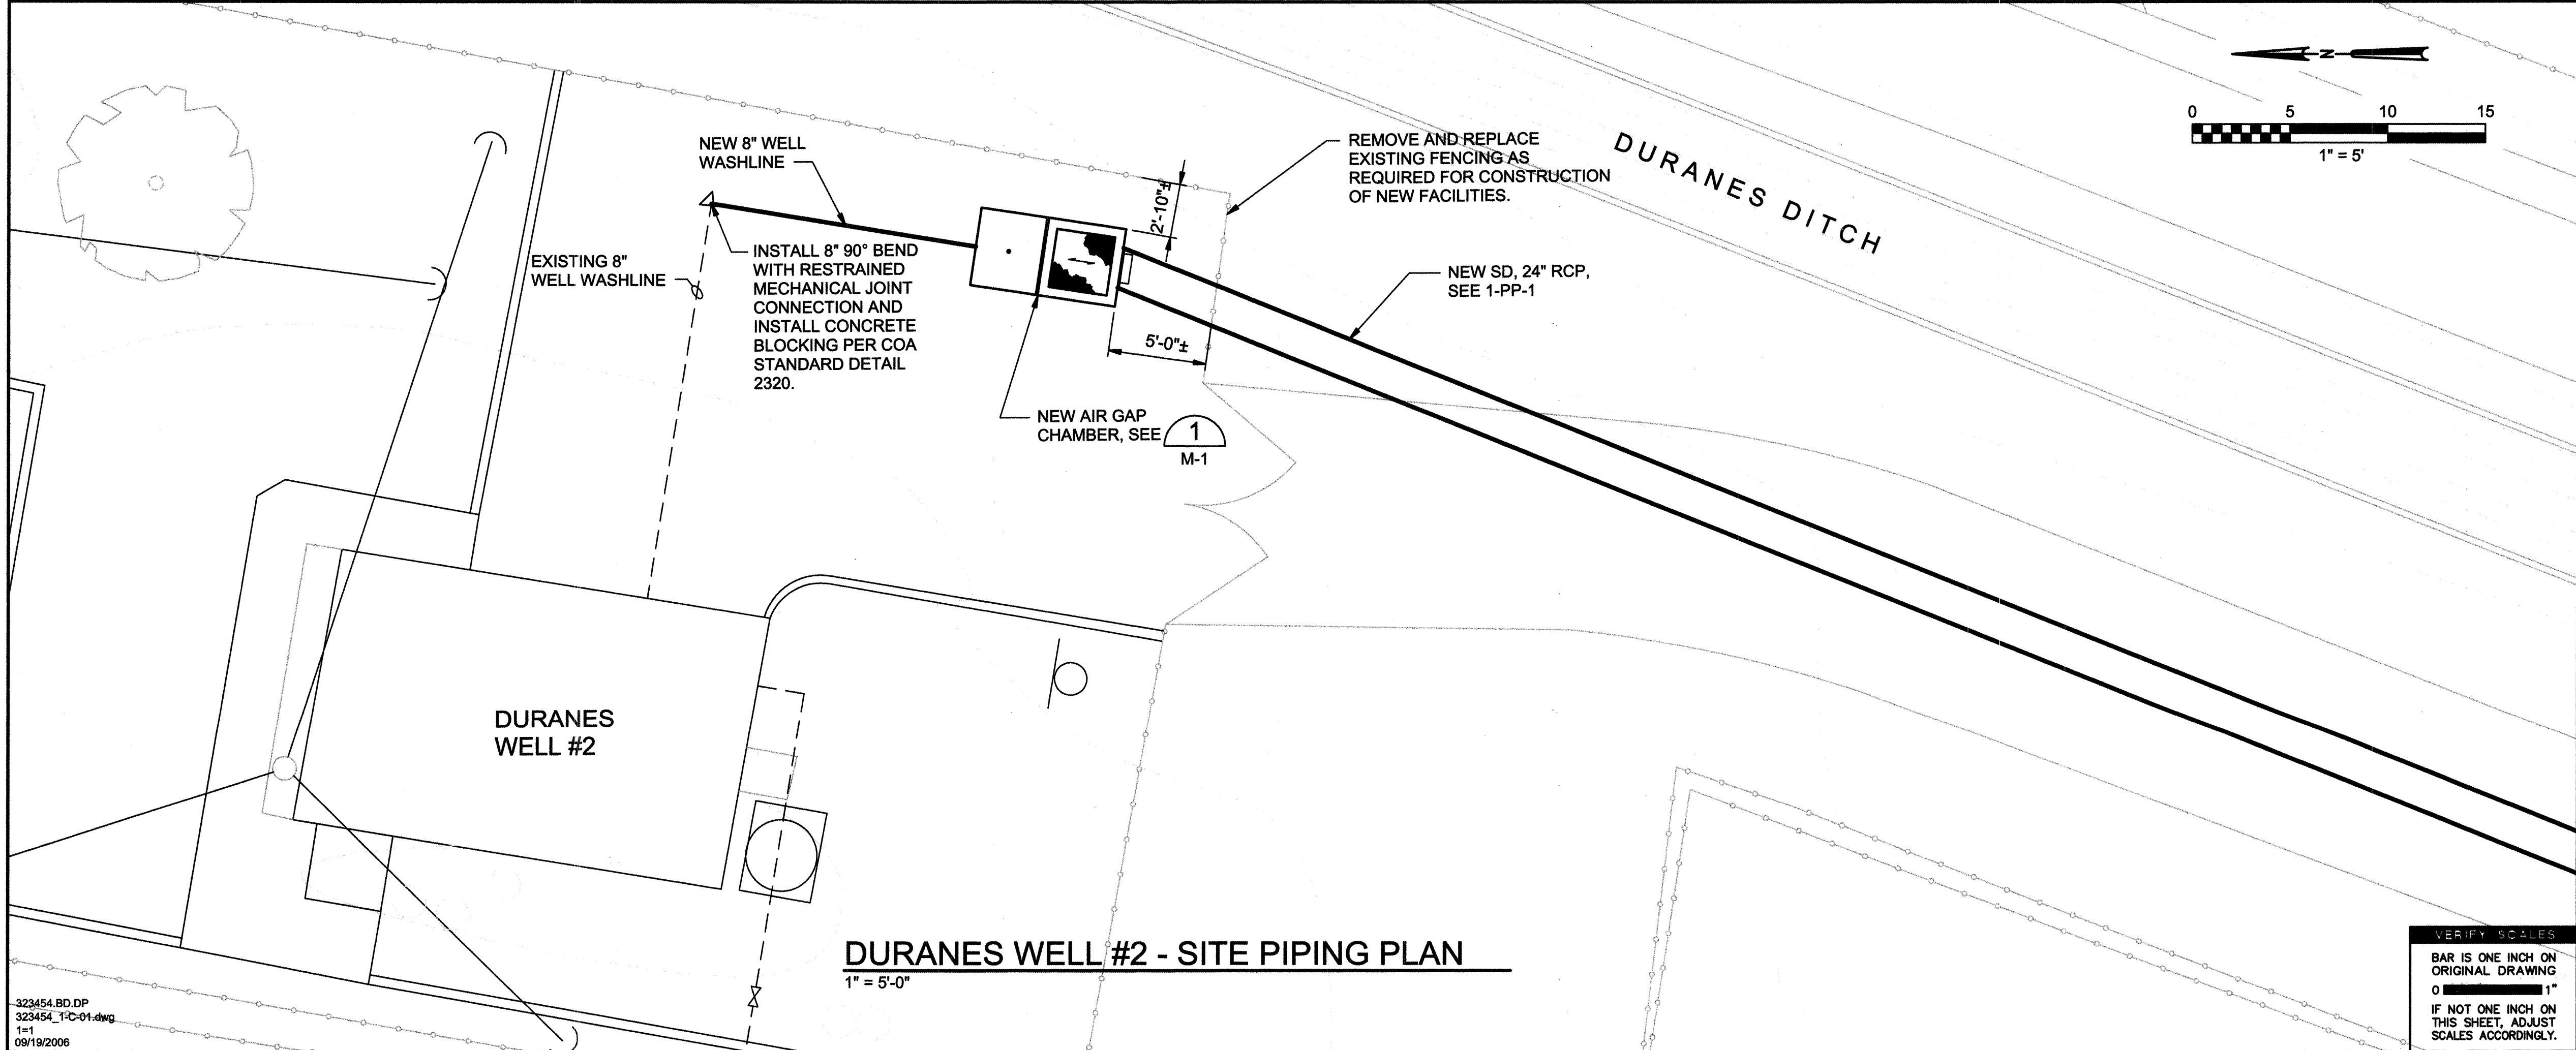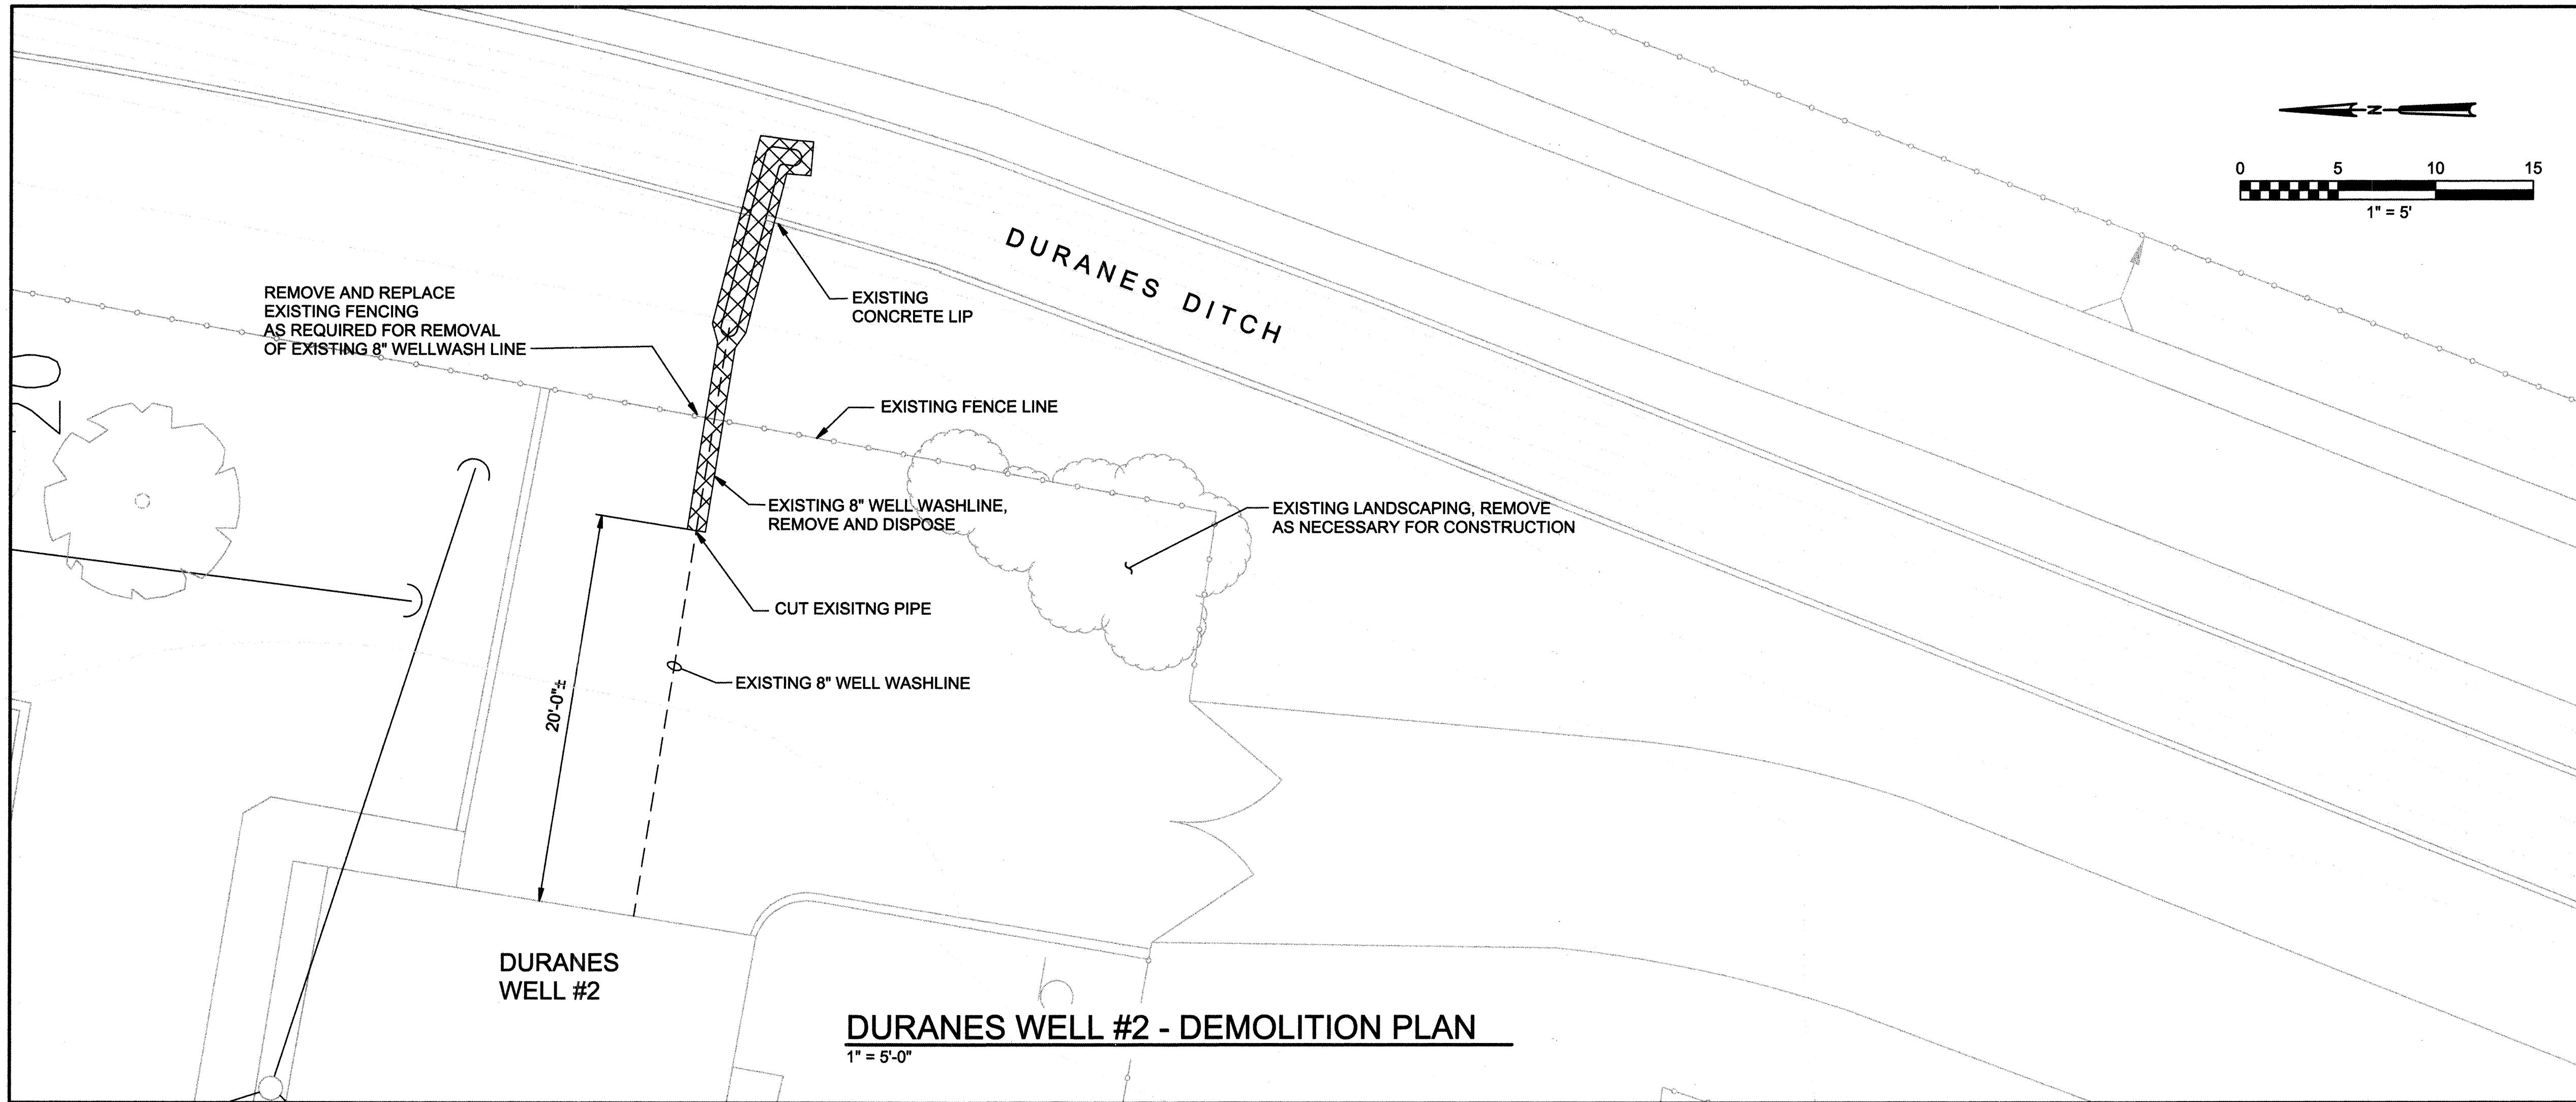

CONSTRUCTION NOTES:

A. REPLACE ALL FENCING, LANDSCAPING, AND OTHER OBJECTS DISTURBED DURING CONSTRUCTION.

B. LANDSCAPING IRRIGATION IS PRESENT IN THE AREA OF CONSTRUCTION. REPAIR AND/OR REPLACE IRRIGATION IF DAMAGED DURING CONSTRUCTION.

C. ALL WORK PERFORMED WITHIN THE MIDDLE RIO GRANDE CONSERVANCY DISTRICT (M.R.G.C.D.) RIGHT-OF-WAY SHALL COMPLY WITH THE M.R.G.C.D. GENERAL CONSTRUCTION NOTES ON THE GENERAL ABBREVIATIONS LEGENDS & NOTES SHEET 2 OF 18.

AS BUILT INFORMATION		BENCH MARKS		SURVEY INFORMATION		ENGINEER'S SEAL	
NO.	DATE	NO.	DATE	NO.	DATE	NO.	DATE
1	08/02/07	BM#1 LOCATED AT THE INTERSECTION OF RIO GRANDE BLVD. N.W. AND MATTHEW AVE. N.W.					
2	08/02/07	STATION IS AN ACS BRASS TABLET, STAMPED "3-G12"					
3	08/02/07	X=373.008 Y=1,499.083 886 EL. =4,963.29					
4	08/02/07	BM#2 LOCATED NEAR THE END OF THE CUL-DE-SAC ON SHERIDAN ST. STATION IS USC&GS BRASS TABLET					
5	08/02/07	STAMPED "888-C.NO. 1, ALBUQUERQUE DISTRICT, 1950"					
6	08/02/07	X=371.825 0808 Y=1,499.849 6127 EL. =4,967.32					
7	08/02/07	HORIZ: NAD 27, VERT: SLD 29					

THIS SHEET SUPERSEDED BY SIMILAR SHEET MARKED "RECORD DRAWING"

CH2MHILL
6001 Indian School Rd, N.E., SUITE 350
Albuquerque, New Mexico 87110
(505) 884-5600

Albuquerque Bernalillo County
Water Utility Authority

TITLE: DURANES WELLS 2, 3 AND 6 WASHLINE MODIFICATIONS
DURANES WELL #2 SITE PIPING / DEMOLITION PLAN


DESIGNED BY	DATE	REVISIONS	BY	DATE
EKH	05/11/2005	DESIGN		
EJA	06/03/2005			
MAB	04/29/2006			

DESIGN REVIEW COMMITTEE
APPROVED SEP 26 2006
DESIGN REVIEW COMMITTEE

CITY ENGINEER APPROVAL
APPROVED SEP 26 2006
CITY ENGINEER

VERIFY SCALES
BAR IS ONE INCH ON ORIGINAL DRAWING
0 1"
IF NOT ONE INCH ON THIS SHEET, ADJUST SCALES ACCORDINGLY.

CITY PROJECT NO. 7279-03
Zone Map No. G-12
SHEET 3 OF 16
DRAWING NO. 1-C-1

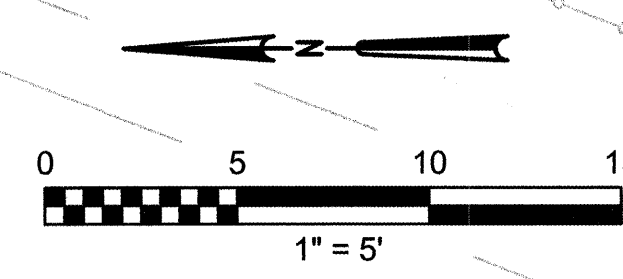

1" = 5'-0"

AS BUILT INFORMATION	DATE
NEW MEXICO UNDERGROUND CONTRACTORS INC.	
CONTRACTOR	
STATED BY: TERRA LAND SURVEYS LLC	DATE: 04/20/2017
INSPECTORS	
CH2MHILL	DATE: 08/20/2017
ACCEPTANCE BY	
CH2MHILL	DATE: 08/20/2017
FIELD LOCATION BY	
CH2MHILL	DATE: 08/20/2017
DRAWINGS	
CORRECTED BY	
CH2MHILL	DATE: 08/20/2017
MICRO FILM INFORMATION	
RECORDED BY	DATE
NO.	

BENCH MARKS

BM#1 LOCATED AT THE INTERSECTION OF RIO GRANDE BLVD. N.W. AND MATTHEW AVE. N.W. STATION IS AN ACS BRASS TABLET, STAMPED "3-G12". X=373.008, 307.9 Y=1,499,083,8586 EL.=4,963.29.

BM#2 LOCATED NEAR THE END OF THE CUL-DE-SAC ON SHERIDAN ST. STATION IS USC&GS BRASS TABLET STAMPED "898-C.NO. 1, ALBUQUERQUE DISTRICT, 1950". X=371,825,0808 Y=1,499,849,6127 EL.=4,967.32

HORIZ: NAD 27, VERT: SLD 29

[illegible]

THESE DRAWINGS
WERE MODIFIED USING
AUTOCAD AND REPLOTTED
FOR RECORD PURPOSES
BY THE ENGINEERS
HAVE THE ENGINEERS STAMP
OR OTHER SIGNATURES THAT
APPEAR ON THE ORIGINAL
CONTRACT DRAWINGS.

[illegible]Revisions Drawn by EJA Date 07/2007



6001 Indian School Rd, N.E., SUITE 350
Albuquerque, New Mexico 87110
(505) 884-5600

[illegible]

Design Review Committee	City Engineer Approval	MOJ Day/ H.	MOJ Day/ H.

CANDIDATE'S NAME		F. M. N.		SHEET 3 OF 10	
------------------	--	----------	--	---------------	--

VERIFY SCALES
BAR IS ONE INCH ON
ORIGINAL DRAWING
0  1
IF NOT ONE INCH ON
THIS SHEET, ADJUST
SCALES ACCORDINGLY

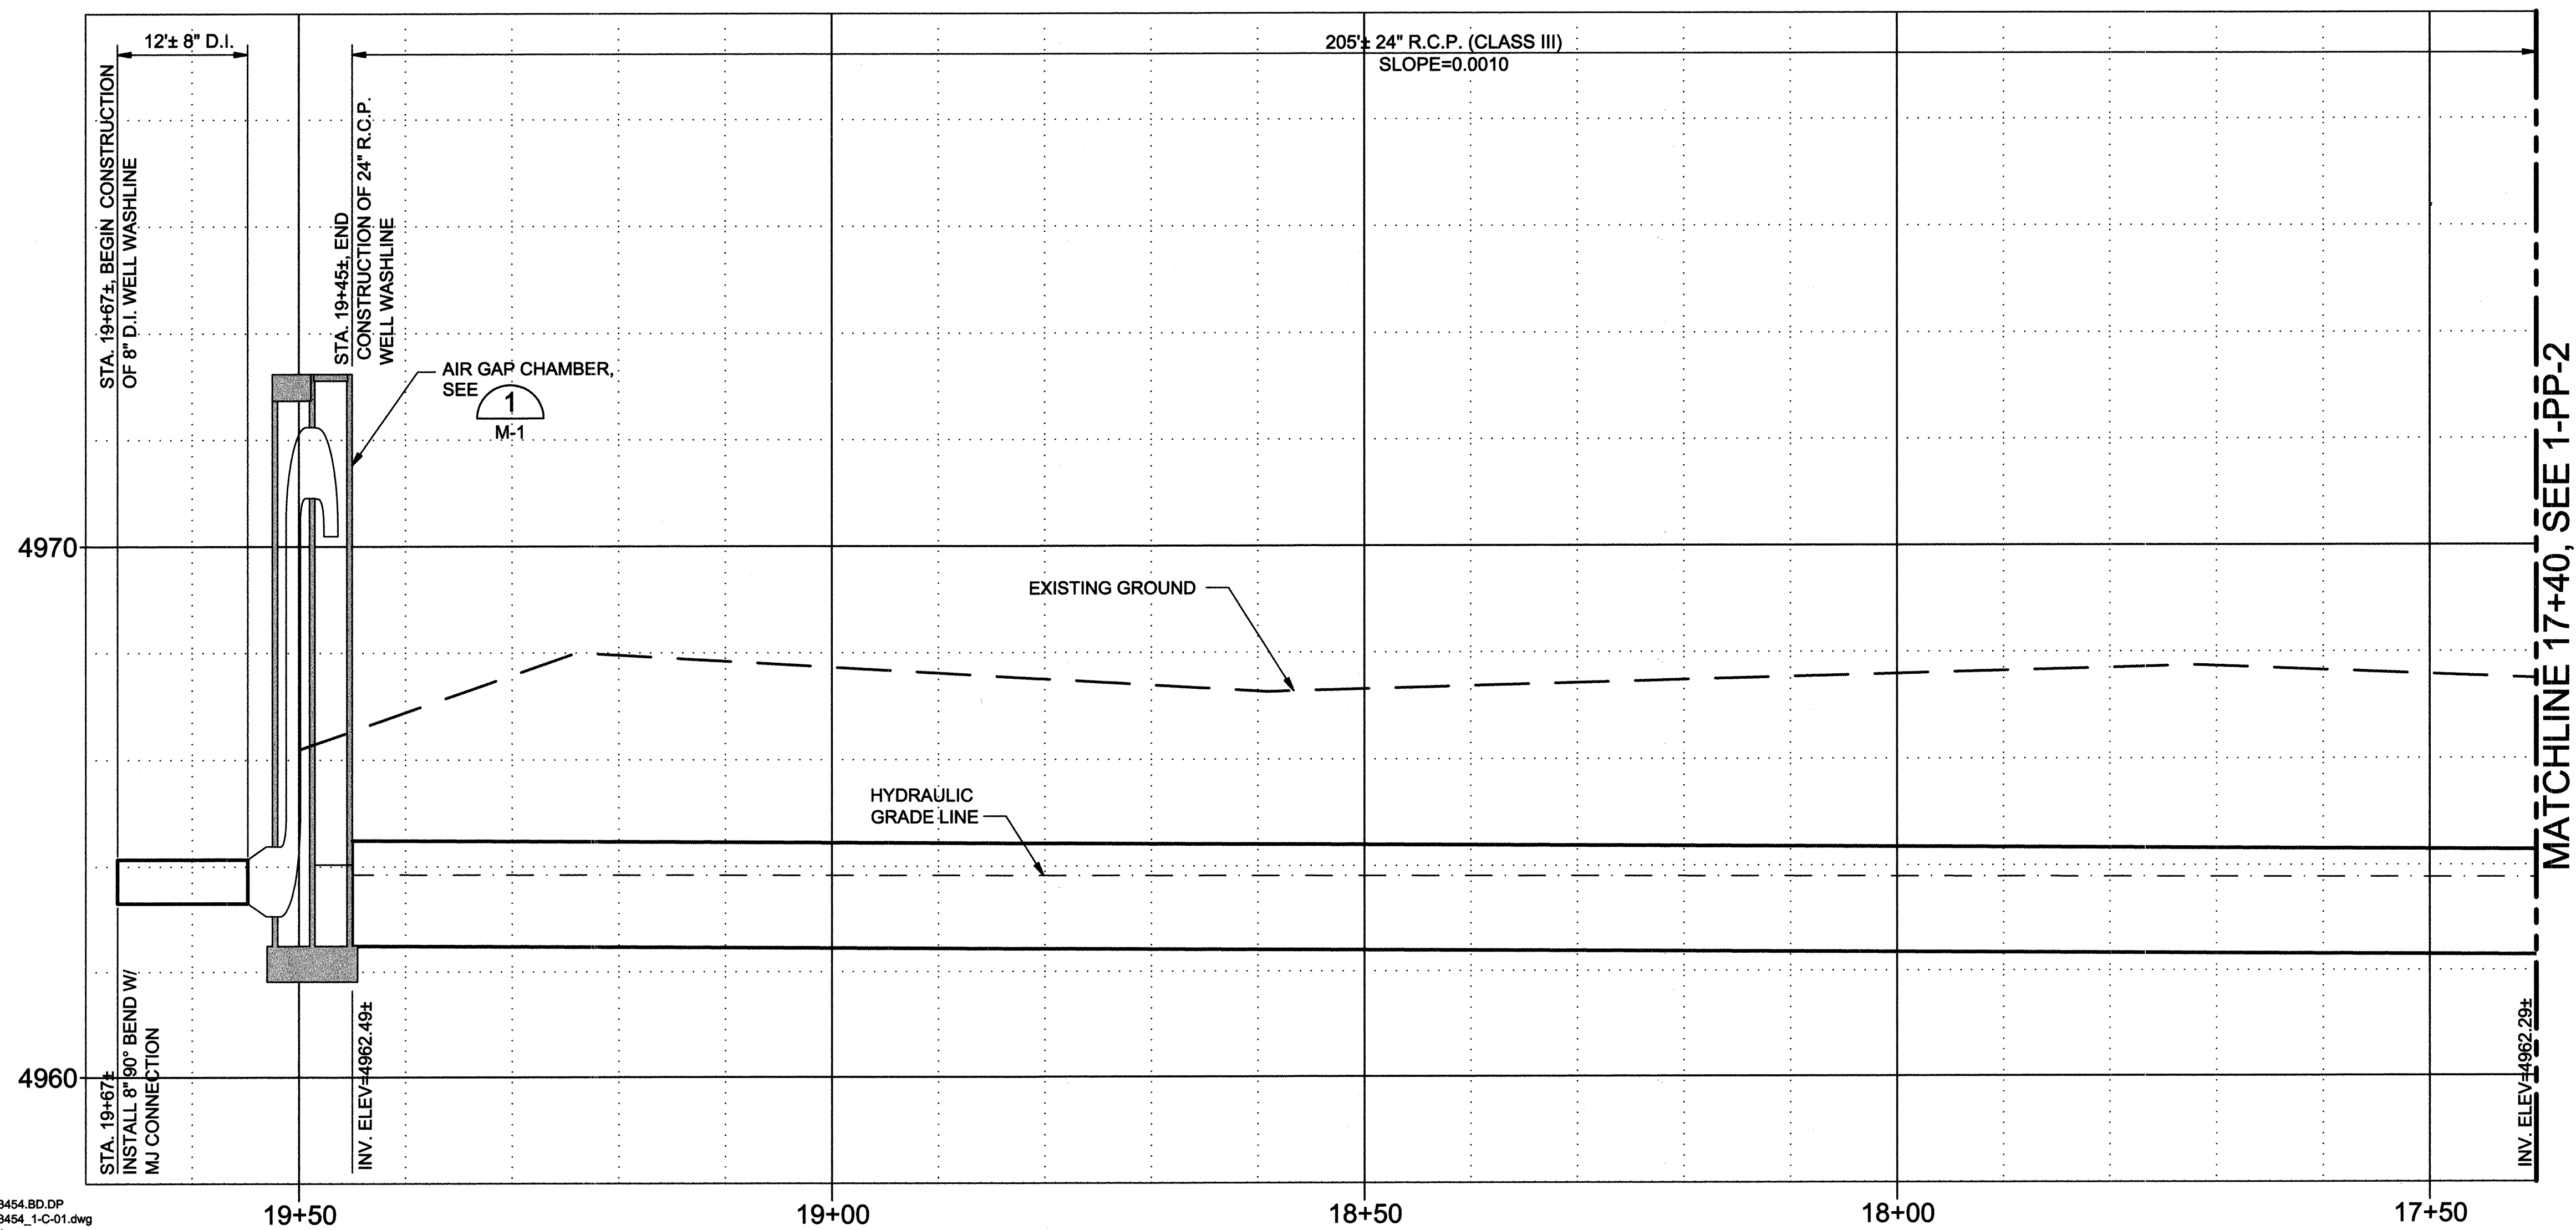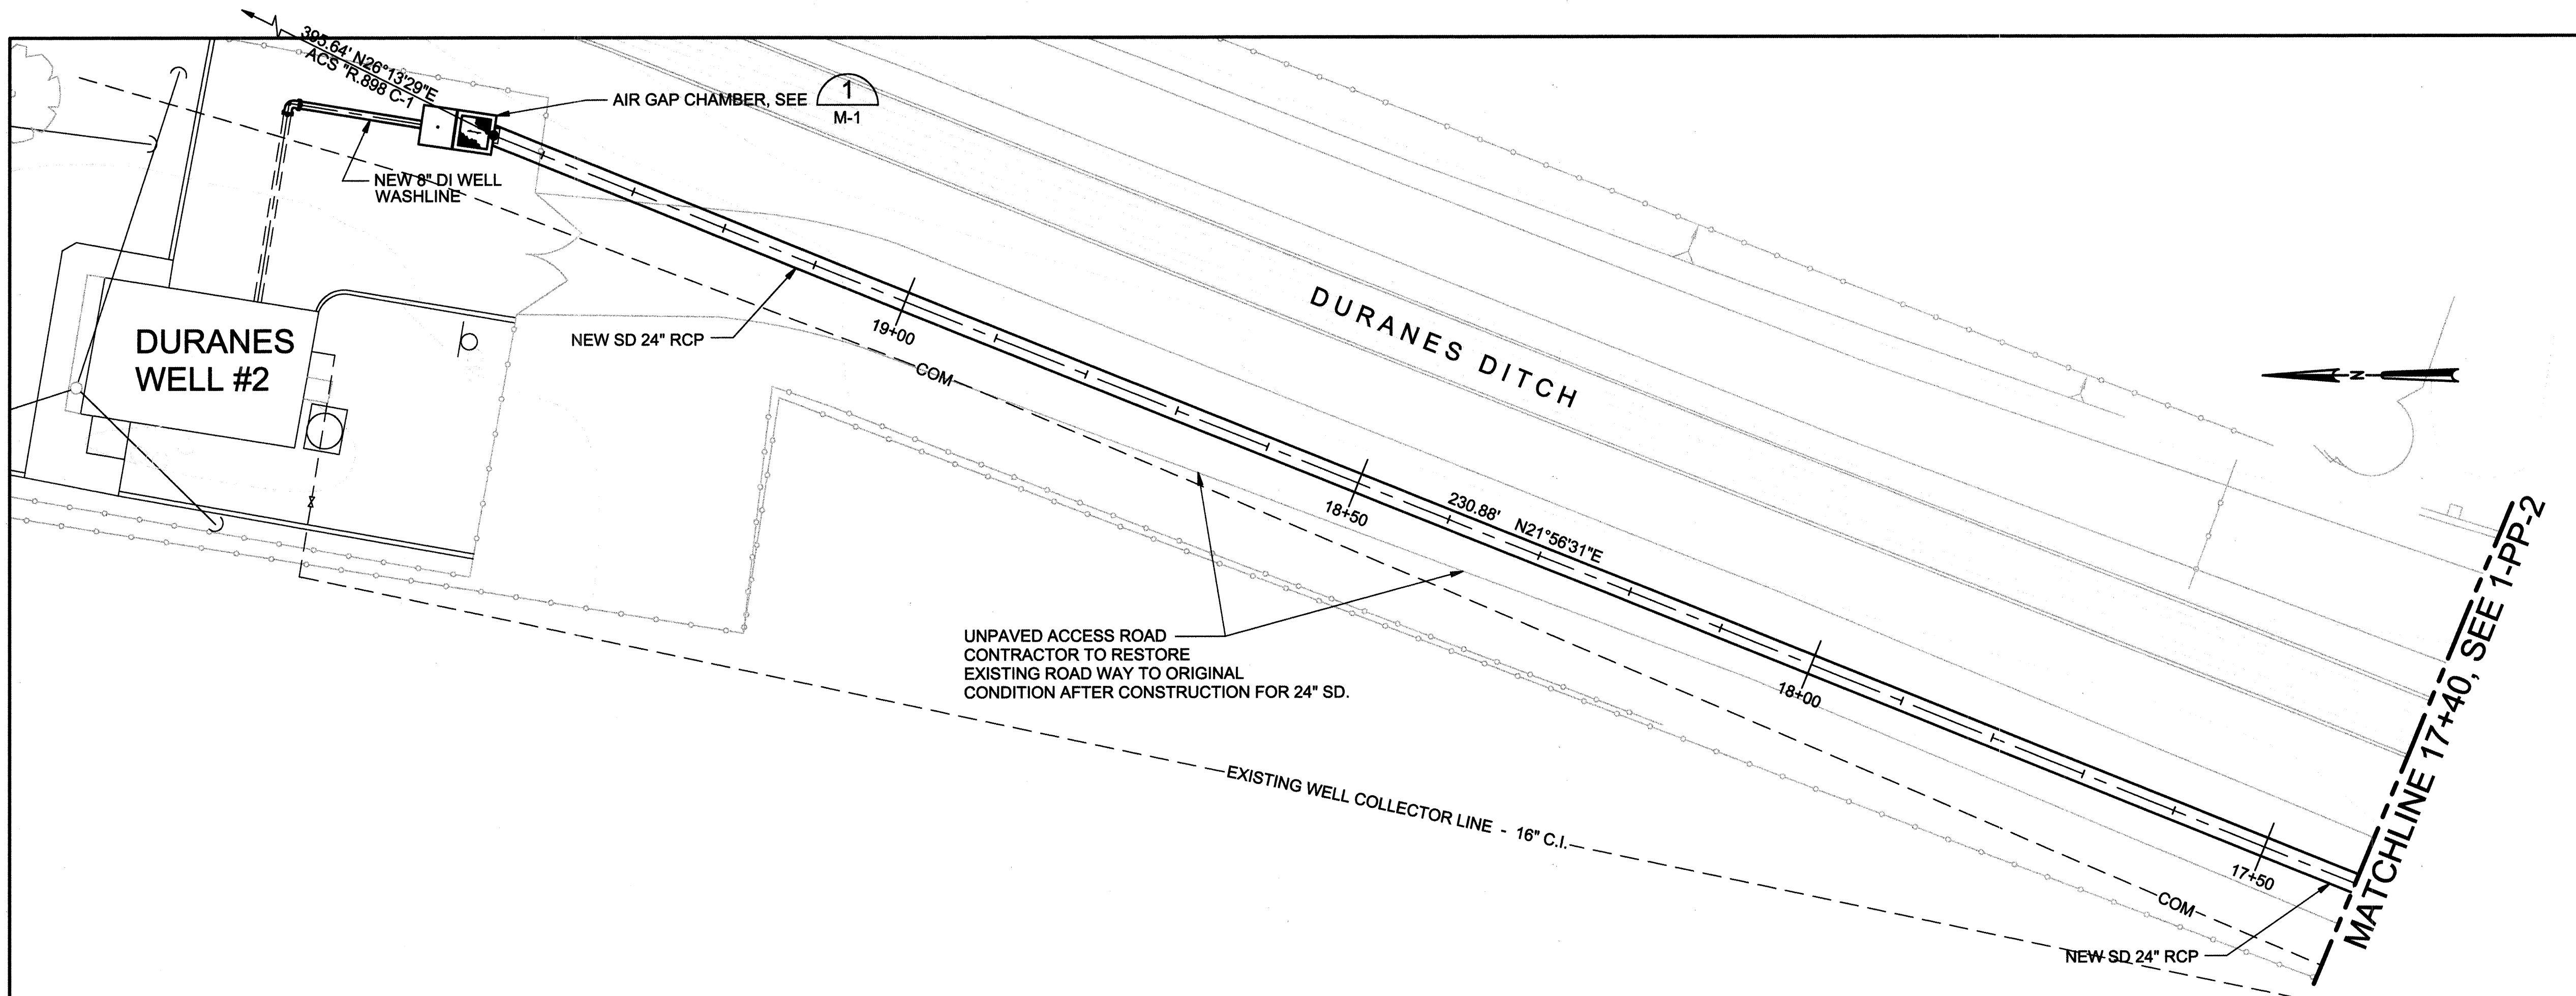

323454.BD.DP
323454_1-C-01.dwg
1=1
09/19/2006

VERIFY SCALES
BAR IS ONE INCH ON ORIGINAL DRAWING
0 1"
IF NOT ONE INCH ON THIS SHEET, ADJUST SCALES ACCORDINGLY.

RECORD DRAWINGS
These record drawings have been prepared, in part, on the basis of information compiled by others. They are not intended to represent in detail the exact location, type of component nor manner of construction. The engineer will not be responsible for any errors or omissions which have been incorporated into the record drawings.

SCALE: HORIZONTAL: 1"=10'
VERTICAL: 1"=2'

CH2MHILL
6001 Indian School Rd, N.E., SUITE 350
Albuquerque, New Mexico 87110
(505) 884-5600


Albuquerque Bernalillo County
Water Utility Authority

TITLE: DURANES WELLS 2, 3 AND 6 WASHLINE MODIFICATIONS
DURANES WELL #2 WASHLINE - STA. 17+40 TO STA. 19+67


DESIGN REVIEW COMMITTEE APPROVE SEP 26 2006 DESIGN REVIEW COMMITTEE	CITY ENGINEER APPROVAL APPROVE SEP 26 2006 CITY ENGINEER	Mo./Day/Yr. ____/____/____	Mo./Day/Yr. ____/____/____
---	--	-------------------------------	-------------------------------

CITY PROJECT NO. 7279-03	Zone Map No. G-12	SHEET 4 OF 16 DRAWING NO. 1-PP-1
--------------------------	-------------------	-------------------------------------

AS BUILT INFORMATION		BENCH MARKS		SURVEY INFORMATION		ENGINEER'S SEAL	
CONTRACTOR	DATE	BM#	LOCATION	NO.	DATE	NO.	DATE
NEW MEXICO UNDERGROUND CONTRACTORS INC.	04/2007	BM#1	LOCATED AT THE INTERSECTION OF RIO GRANDE BLVD. N.W. AND MATTHEW AVE. N.W.				
INSPECTORS	DATE						
CH2MHILL	08/2007		STATION IS AN ACS BRASS TABLET, STAMPED "3-G12"				
ACCEPTANCE BY	DATE		X=373,008.3079 Y=1,499,083.8686 EL.=4,963.29				
VERIFICATION BY	DATE		BM#2 LOCATED NEAR THE END OF THE CUL-DE-SAC ON SHERIDAN ST. STATION IS USC&GS BRASS TABLET				
CH2MHILL	08/2007		STAMPED "895-C-NO. 1, ALBUQUERQUE DISTRICT, 1950"				
REVISIONS	DATE		X=371,825.0808 Y=1,499,849.6127 EL.=4,967.32				
CH2MHILL	08/2007		HORIZ: NAD 27, VERT: SLD 28				
MICRO FILM INFORMATION							

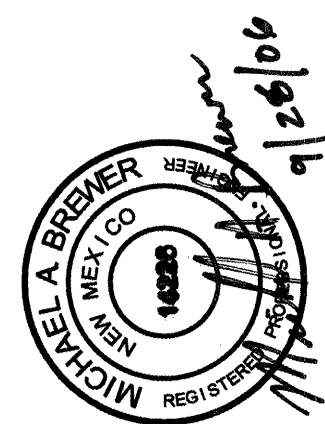

NO.	DATE	REMARKS	BY
		DESIGN	
	05/11/2005	DATE	EKH
	06/03/2005	DATE	EJA
	04/29/2006	DATE	MAB

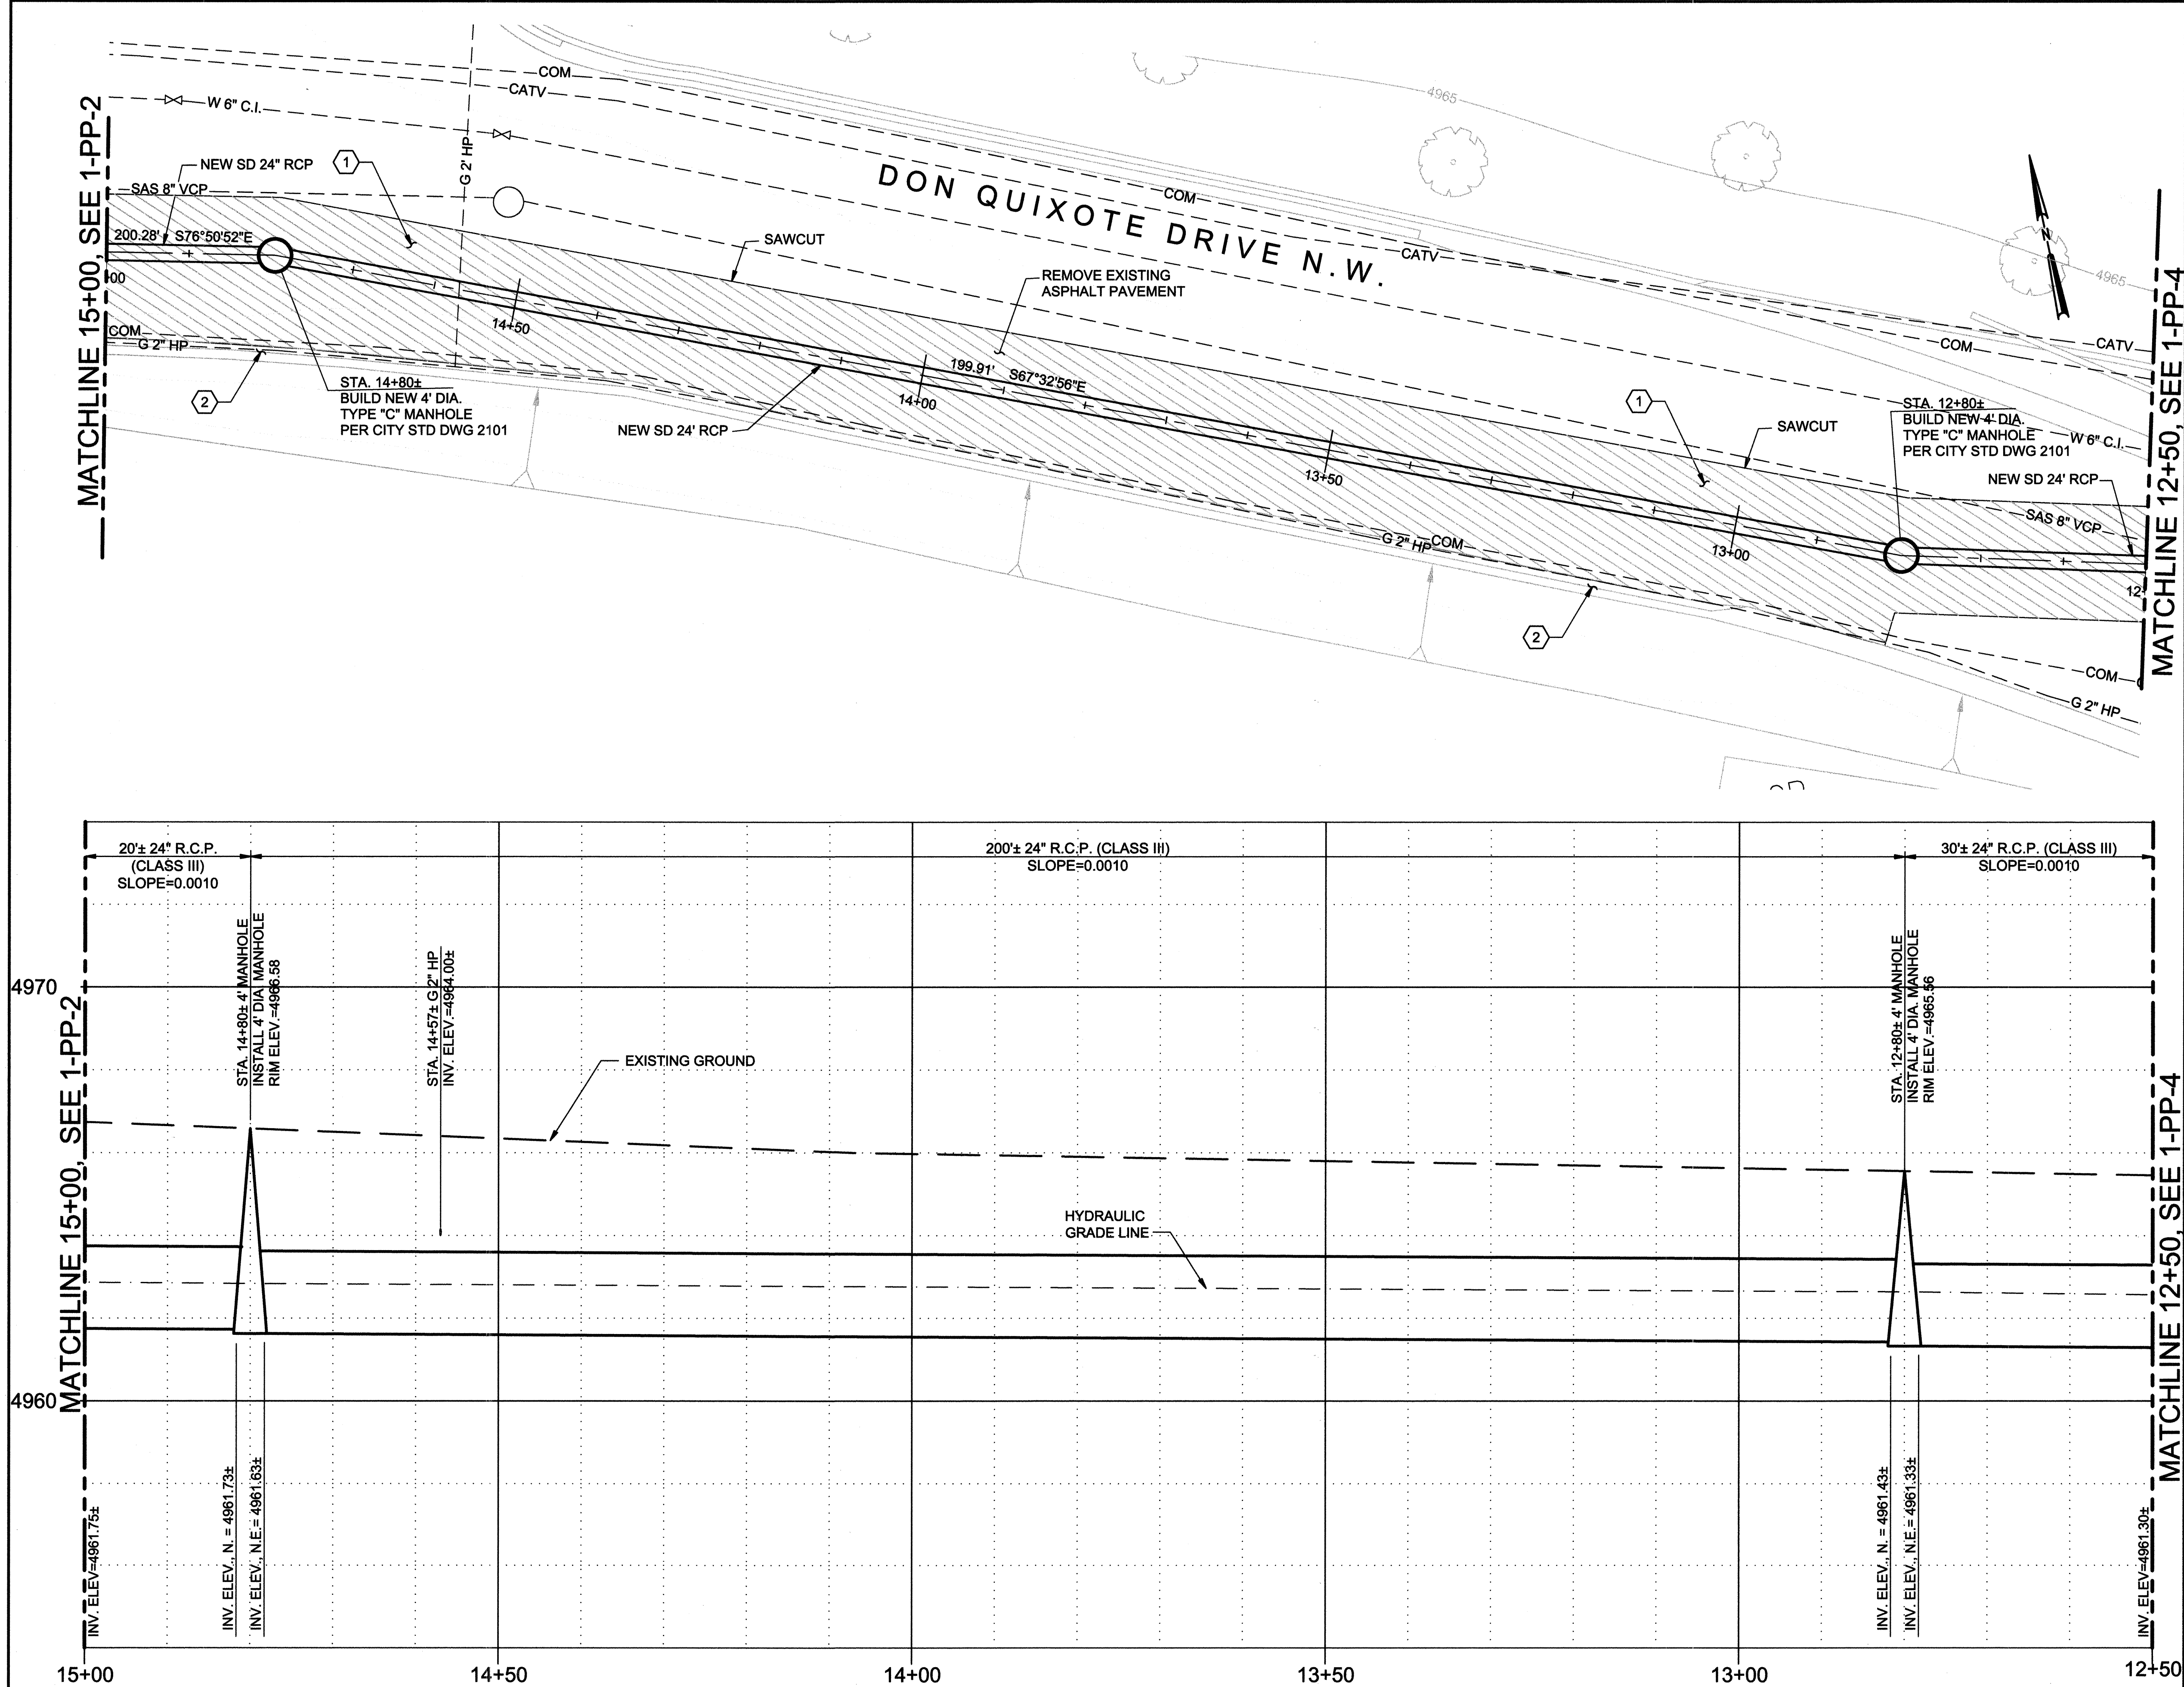

- KEYED NOTES**
- 1 REMOVE AND REPLACE ASPHALT PAVEMENT PER COA STD DWG 2465. PAVEMENT CUTS MUST BE ORTHOGONAL TO FLOW OF TRAFFIC.
 - 2 EXISTING MOUNTABLE CURB AND GUTTER TO REMAIN.

RECORD DRAWINGS
 Revisions Drawn by: EJA Date: 07/2007
 THESE RECORD DRAWINGS HAVE BEEN PREPARED, IN PART, ON THE BASIS OF INFORMATION COMPILED BY OTHERS. THEY ARE NOT INTENDED TO REPRESENT IN DETAIL THE EXACT LOCATION, TYPE OF COMPONENT OR MANNER OF CONSTRUCTION. THE ENGINEER WILL NOT BE RESPONSIBLE FOR ANY ERRORS OR OMISSIONS WHICH HAVE BEEN INCORPORATED INTO THE RECORD DRAWINGS.

SCALE: HORIZONTAL: 1"=10'
 VERTICAL: 1"=2'

CH2MHILL
 6001 Indian School Rd, N.E., SUITE 350
 Albuquerque, New Mexico 87110
 (505) 884-5600


Albuquerque Bernalillo County
Water Utility Authority

TITLE: DURANES WELLS 2, 3 AND 6 WASHLINE MODIFICATIONS
DURANES WELL #2 WASHLINE - STA. 12+50 TO STA. 15+00




DESIGN REVIEW COMMITTEE	CITY ENGINEER APPROVAL	Mo./Day/Yr.	Mo./Day/Yr.
SEP 26 2006	SEP 26 2006		
DESIGN REVIEW COMMITTEE	CITY ENGINEER		

CITY PROJECT NO. 7279-03 Zone Map No. G-12 SHEET 6 OF 16
 DRAWING NO. 1-PP-3

SURVEY INFORMATION		BENCH MARKS		AS BUILT INFORMATION	
FIELD NOTES		DATE		CONTRACTOR	
NO.	BY				
		BM#1 LOCATED AT THE INTERSECTION OF RIO GRANDE BLVD. N.W. AND MATTHEW AVE. N.W.		CONTRACTOR: TERRALAND SURVEYS, LLC. DATE: 04/2007	
		STATION IS AN ACS BRASS TABLET, STAMPED "3-G12".		INSPECTOR: CH2MHILL DATE: 08/2007	
		X=373,008.3079 Y=1,499,083.8586 EL.=4,963.29.		DRAWINGS: CH2MHILL DATE: 08/2007	
		BM#2 LOCATED NEAR THE END OF THE CUL-DE-SAC ON SHERIDAN ST. STATION IS USCSGS BRASS TABLET		CONTRACTOR: CH2MHILL DATE: 08/2007	
		STAMPED "888-C NO. 1, ALBUQUERQUE DISTRICT, 1950"		MICRO FILM INFORMATION	
		X=371,825.0808 Y=1,499,849.6127 EL.=4,967.32		RECORDED BY	
		HORIZ. NAD 27, VERT. SLD 29		NO.	

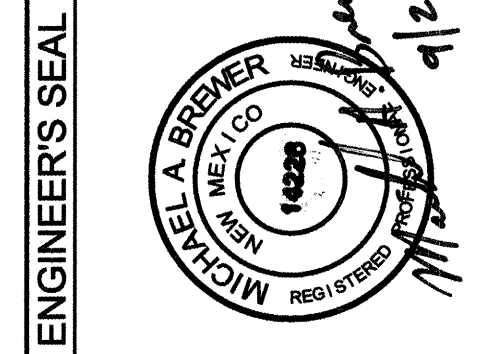

NO.	DATE	REVISIONS	BY
		DESIGN	
DESIGNED BY	EKH	DATE	05/11/2005
DRAWN BY	EJA	DATE	06/03/2005
CHECKED BY	MAB	DATE	04/29/2006

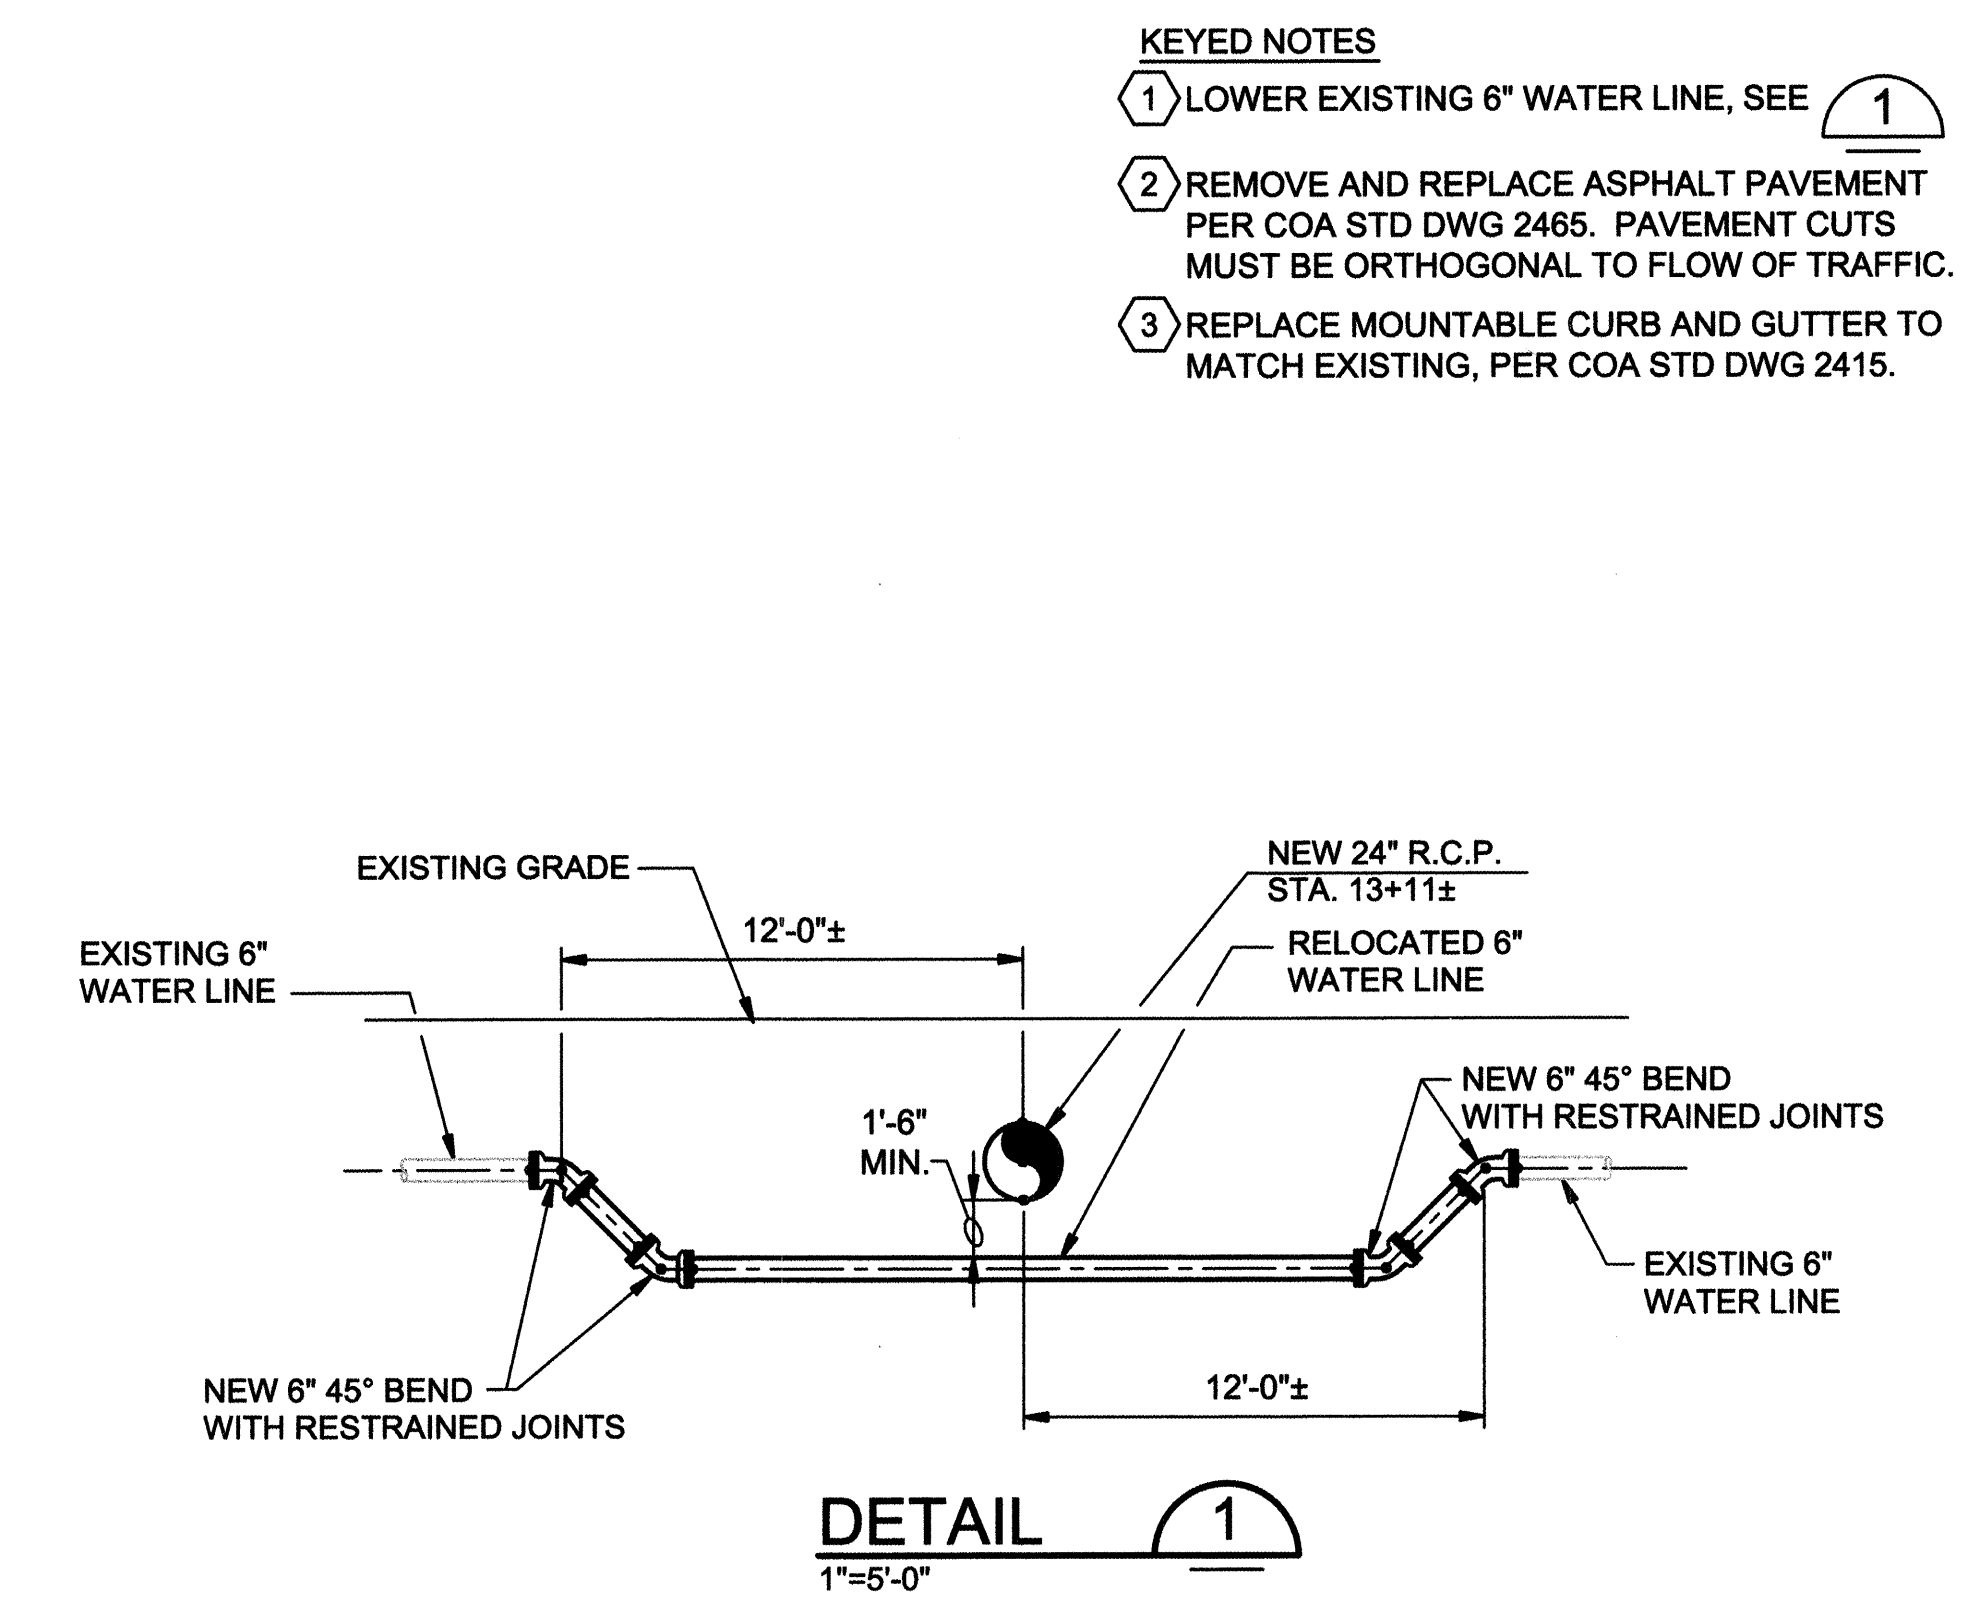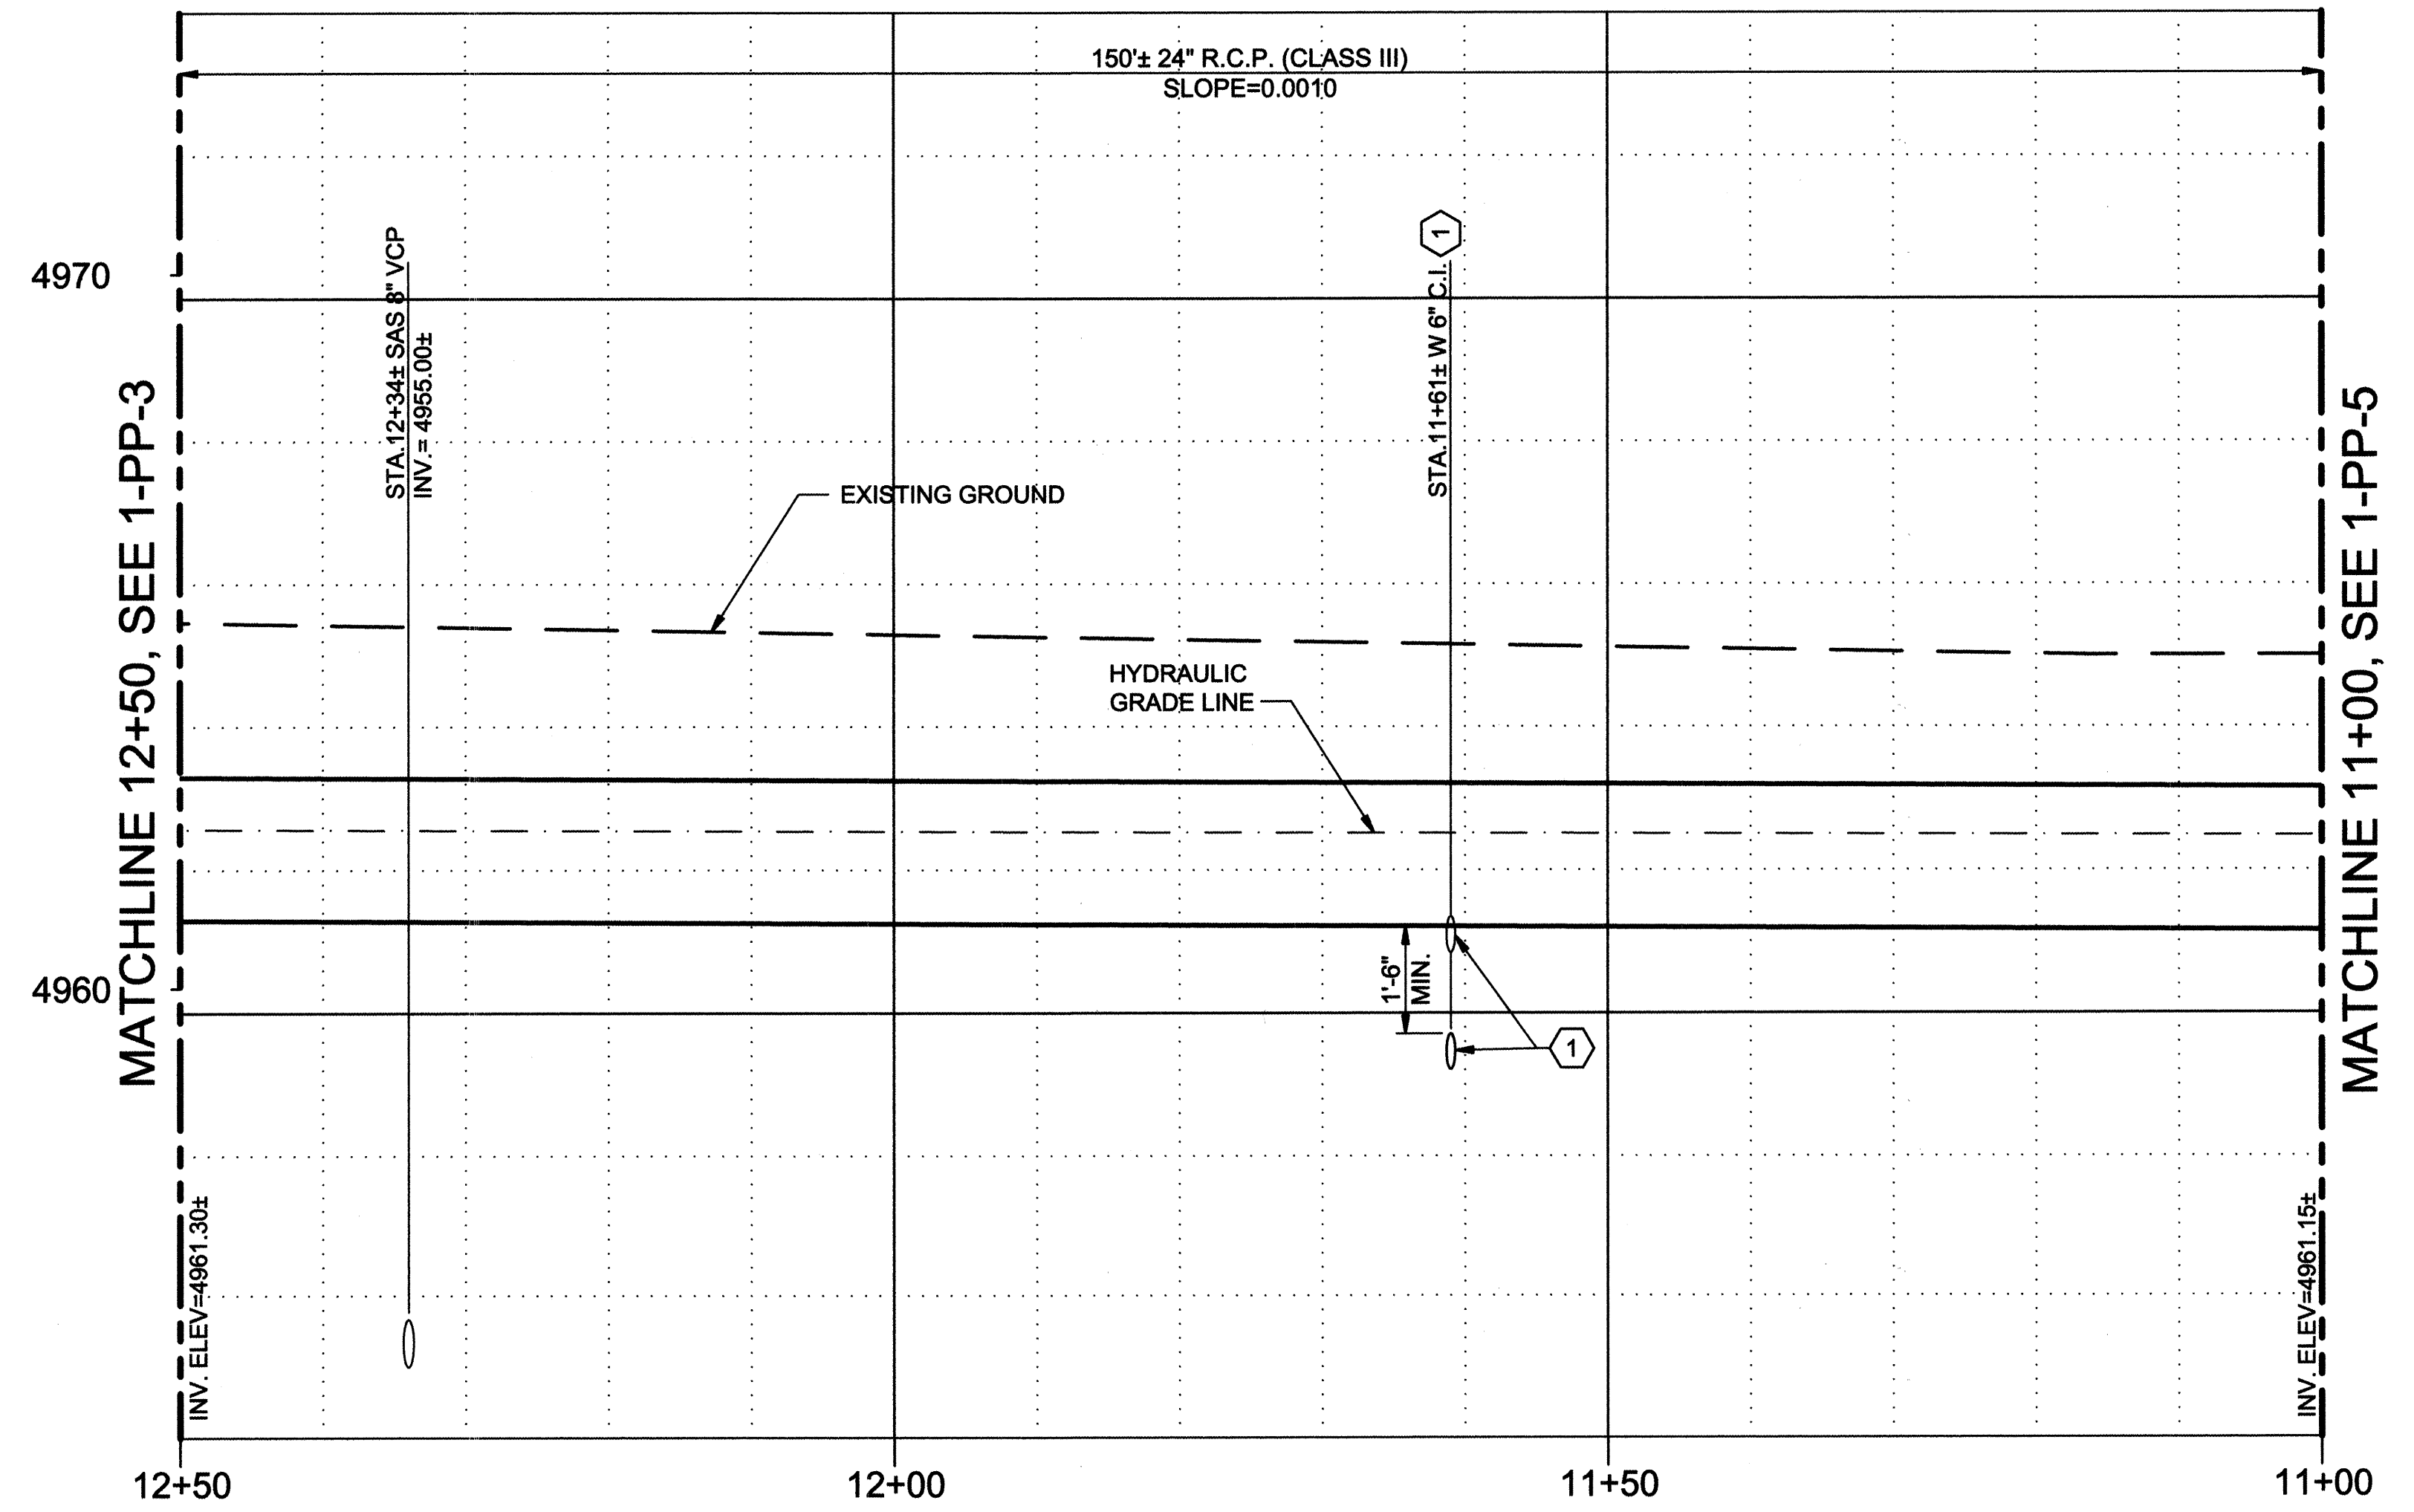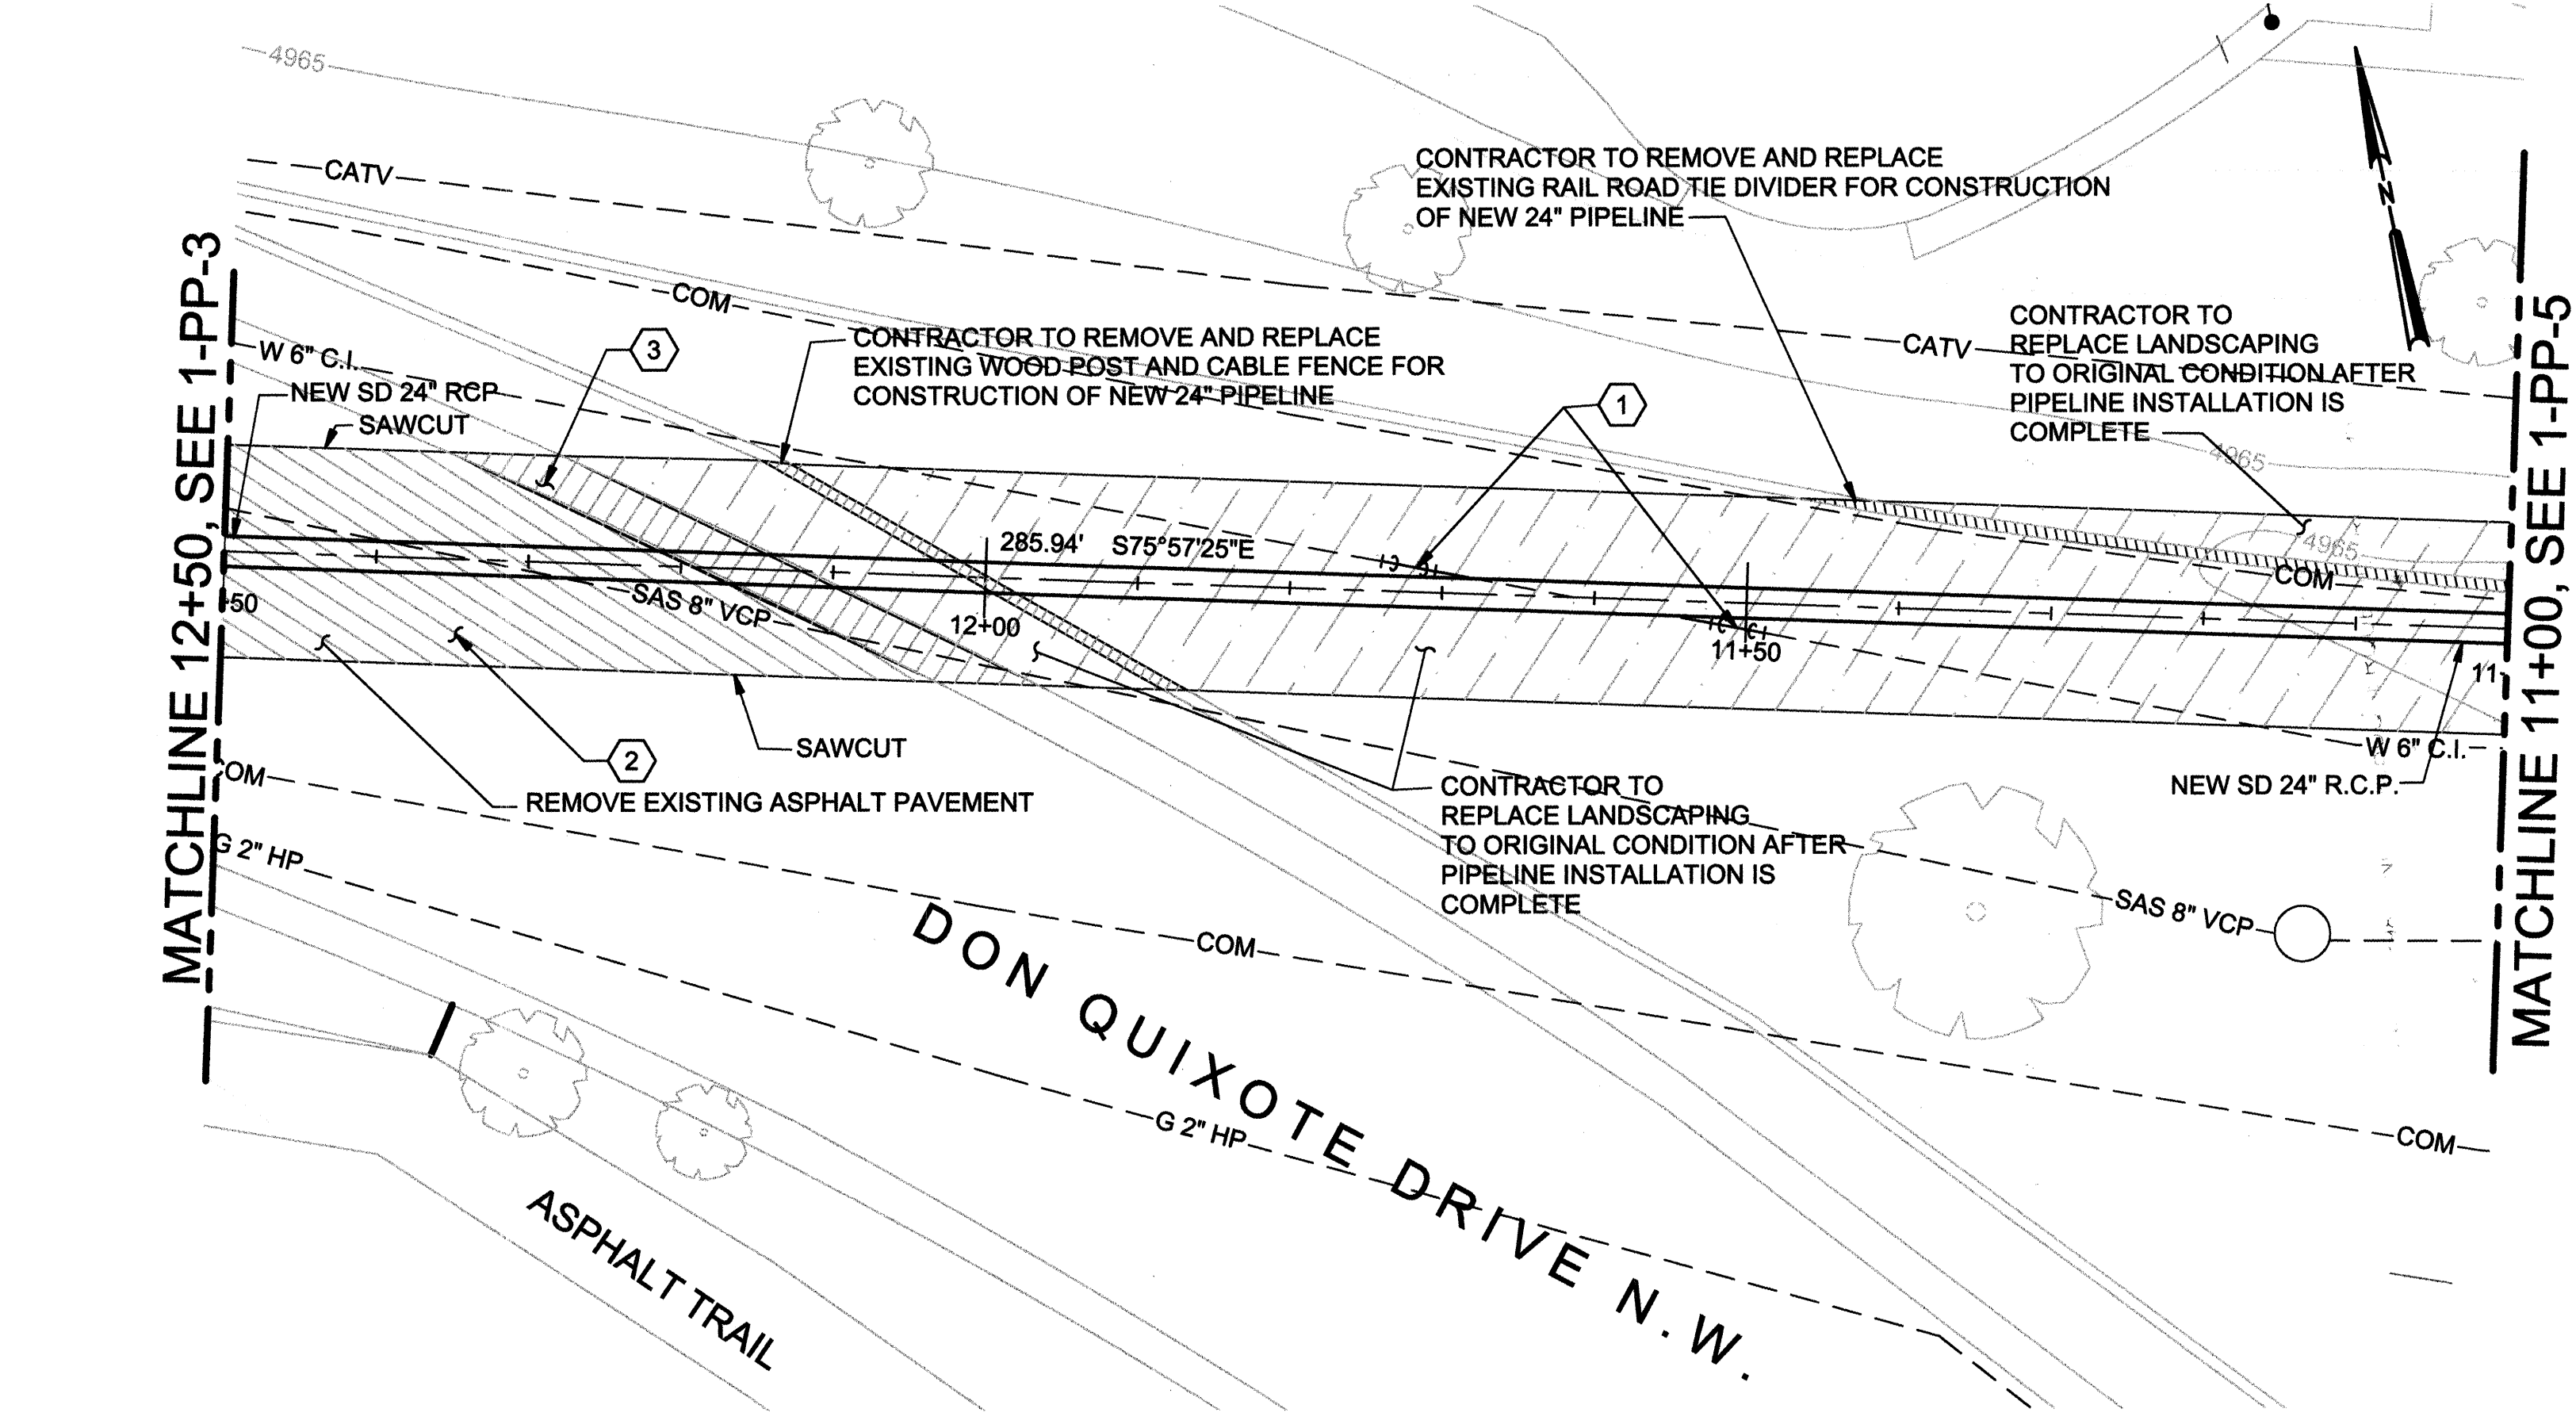

RECORD DRAWINGS
Revisions Drawn by: EJA Date: 07/2005



THESE RECORD DRAWINGS HAVE BEEN PREPARED, IN PART, ON THE BASIS OF INFORMATION COMPILED BY OTHERS. THEY ARE NOT INTENDED TO REPRESENT IN DETAIL THE EXACT LOCATION, TYPE OF COMPONENT NOR MANNER OF CONSTRUCTION. THE ENGINEER WILL NOT BE RESPONSIBLE FOR ANY ERRORS OR OMISSIONS WHICH HAVE BEEN INCORPORATED INTO THE RECORD DRAWINGS.

SCALE: HORIZONTAL: 1"=10'
VERTICAL: 1"=2'

CH2MHILL
6001 Indian School Rd, N.E., SUITE 350
Albuquerque, New Mexico 87110
(505) 884-5600

Albuquerque Bernalillo County	
Water Utility Authority	
TITLE: DURANES WELLS 2, 3 AND 6 WASHLINE MODIFICATIONS	
DURANES WELL #2 WASHLINE - STA. 11+00 TO STA. 12+50	
Design Review Committee	City Engineer Approval
SEP 26 2006	SEP 26 2006
DESIGN REVIEW COMMITTEE	CITY ENGINEER
CITY PROJECT NO. 7279-03	Zone Map No. G-12
SHEET 7 OF 16	DRAWING NO. 1-PP-4

AS BUILT INFORMATION		BENCH MARKS		SURVEY INFORMATION		ENGINEER'S SEAL	
CONTRACTOR: NEW MEXICO UNDERGROUND CONTRACTORS INC.	WORKS BY: TERRALAND SURVEYS LLC	DATE: 04/2007	INSPECTED BY: CH2MHILL	DATE: 08/2007	NO.	BY	REMARKS
VERIFICATION BY: CH2MHILL	DATE: 08/2007	STATION IS AN ACS BRASS TABLET, STAMPED "3-G12"	DATE: 08/2007	DATE	NO.	BY	REMARKS
VERIFICATION BY: CH2MHILL	DATE: 08/2007	BM#2 LOCATED NEAR THE END OF THE CUL-DE-SAC ON SHERIDAN ST. STATION IS USC&GS BRASS TABLET	DATE: 08/2007	DATE	NO.	BY	REMARKS
VERIFICATION BY: CH2MHILL	DATE: 08/2007	STAMPED "898-C.NO. 1, ALBUQUERQUE DISTRICT, 1950"	DATE: 08/2007	DATE	NO.	BY	REMARKS
VERIFICATION BY: CH2MHILL	DATE: 08/2007	X=371,825.0808 Y=1,499,849.6127 EL.=4,967.32	DATE: 08/2007	DATE	NO.	BY	REMARKS
VERIFICATION BY: CH2MHILL	DATE: 08/2007	HORIZ: NAD 27, VERT: SLD 29	DATE: 08/2007	DATE	NO.	BY	REMARKS

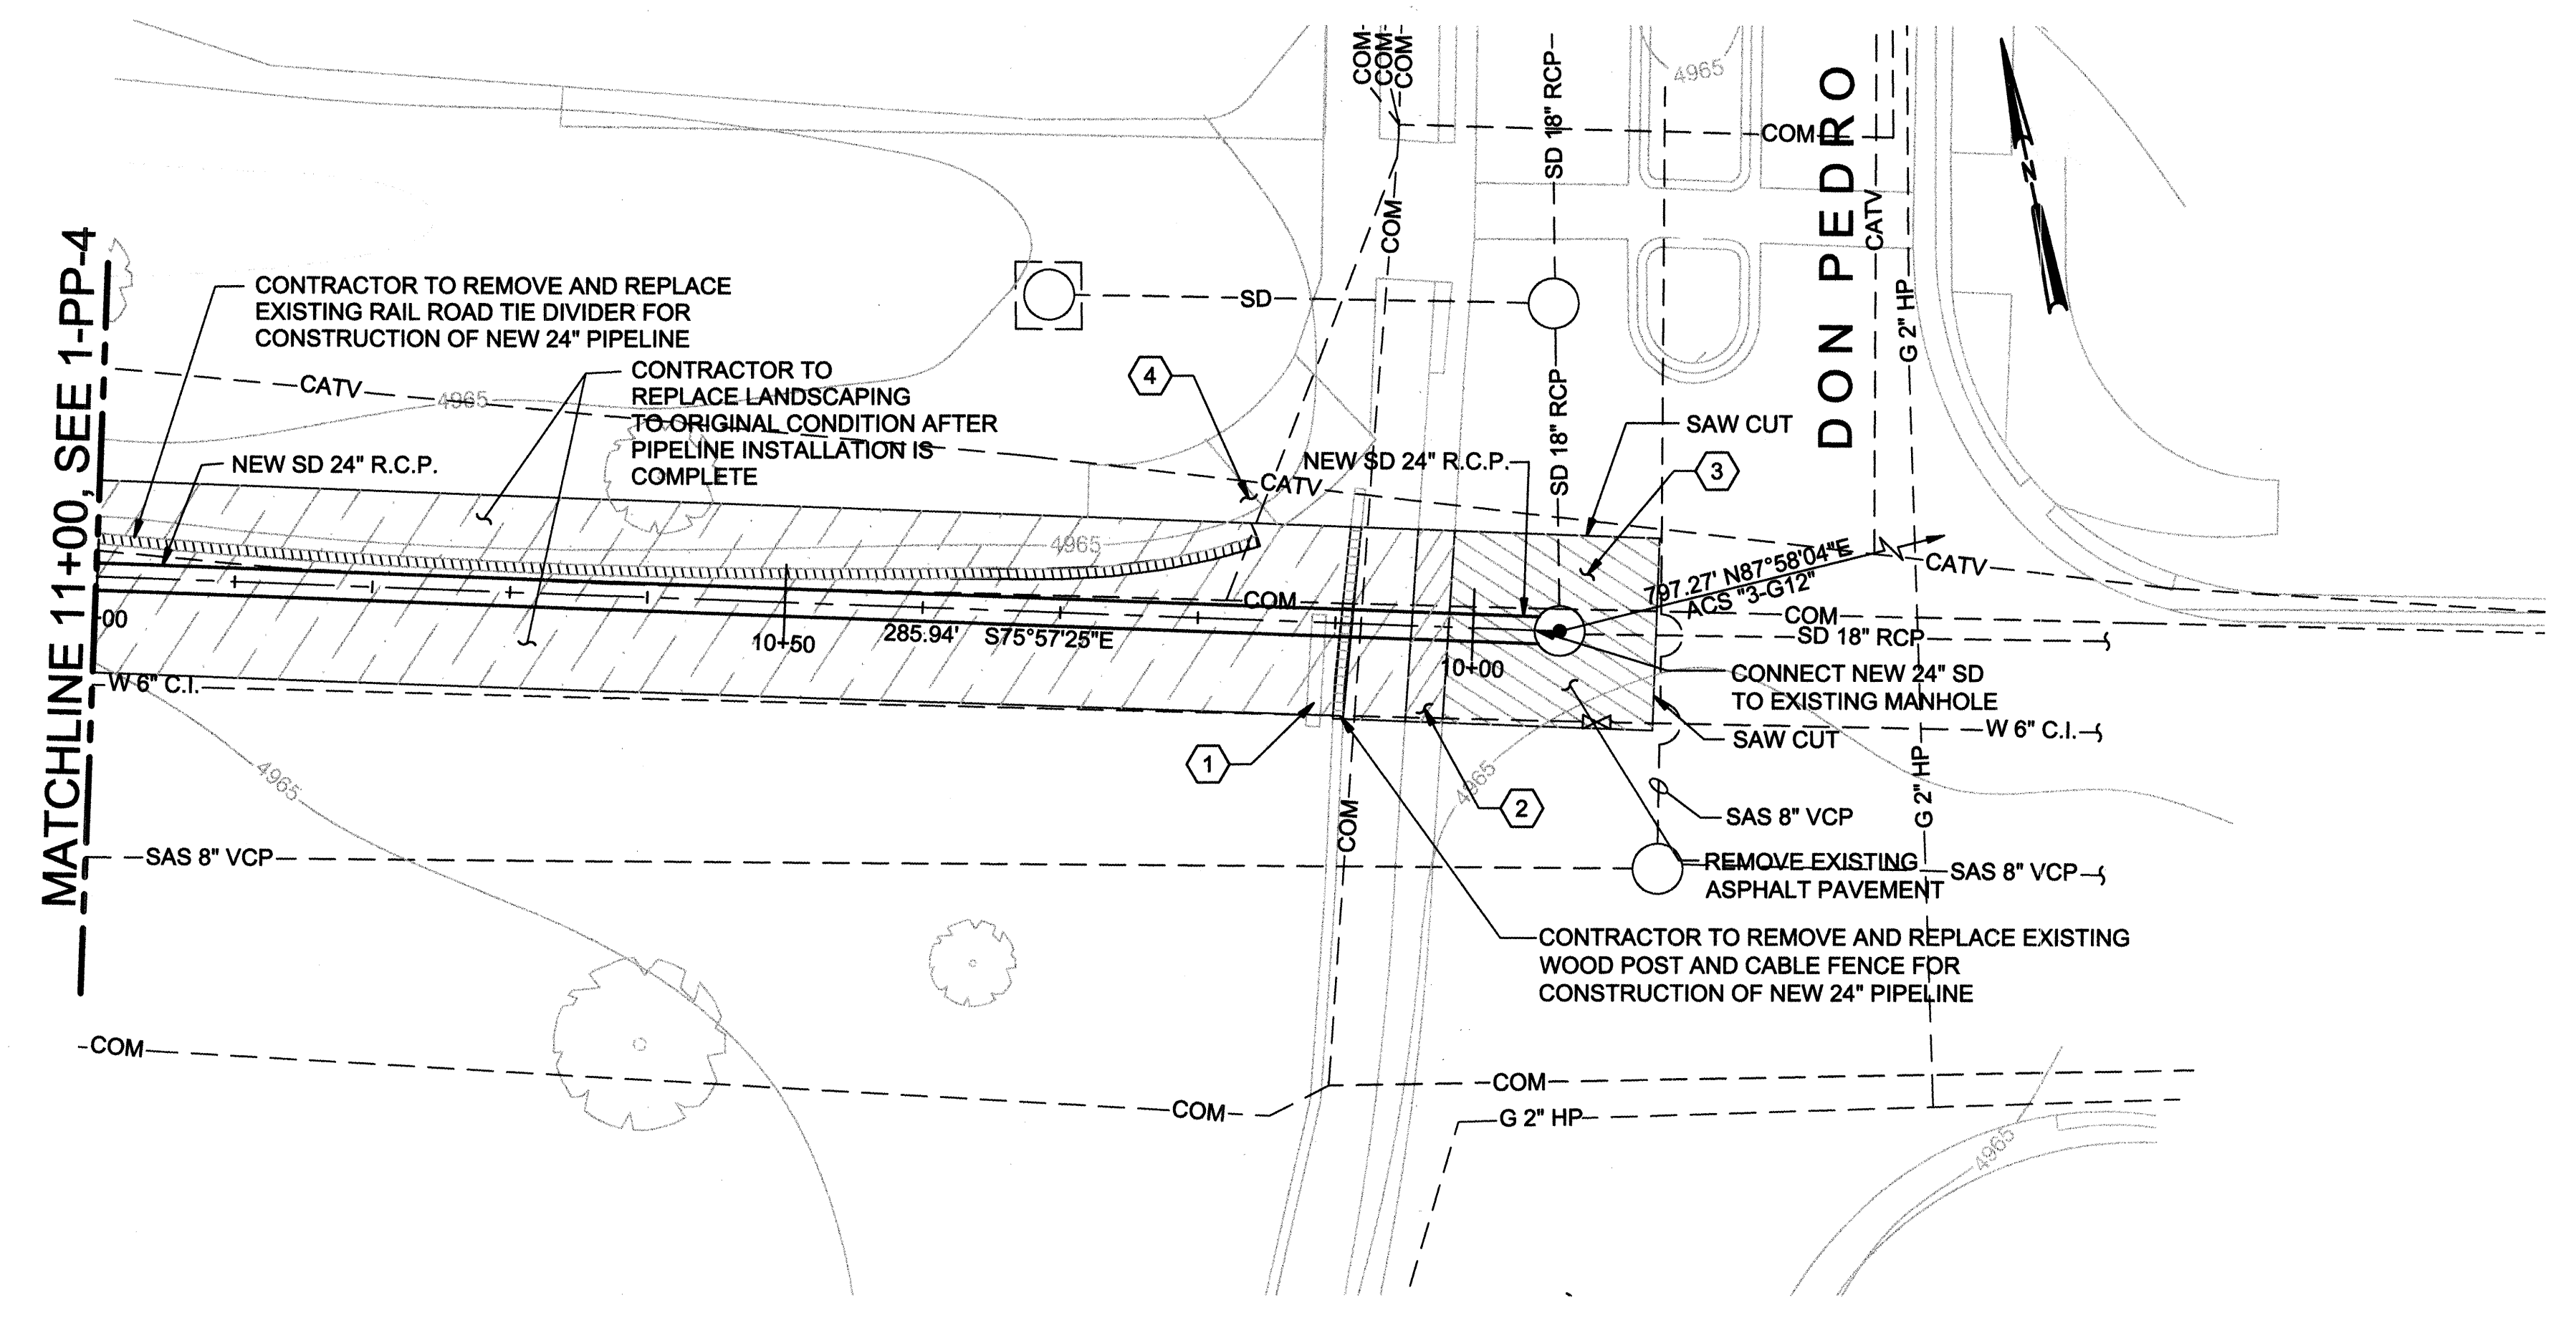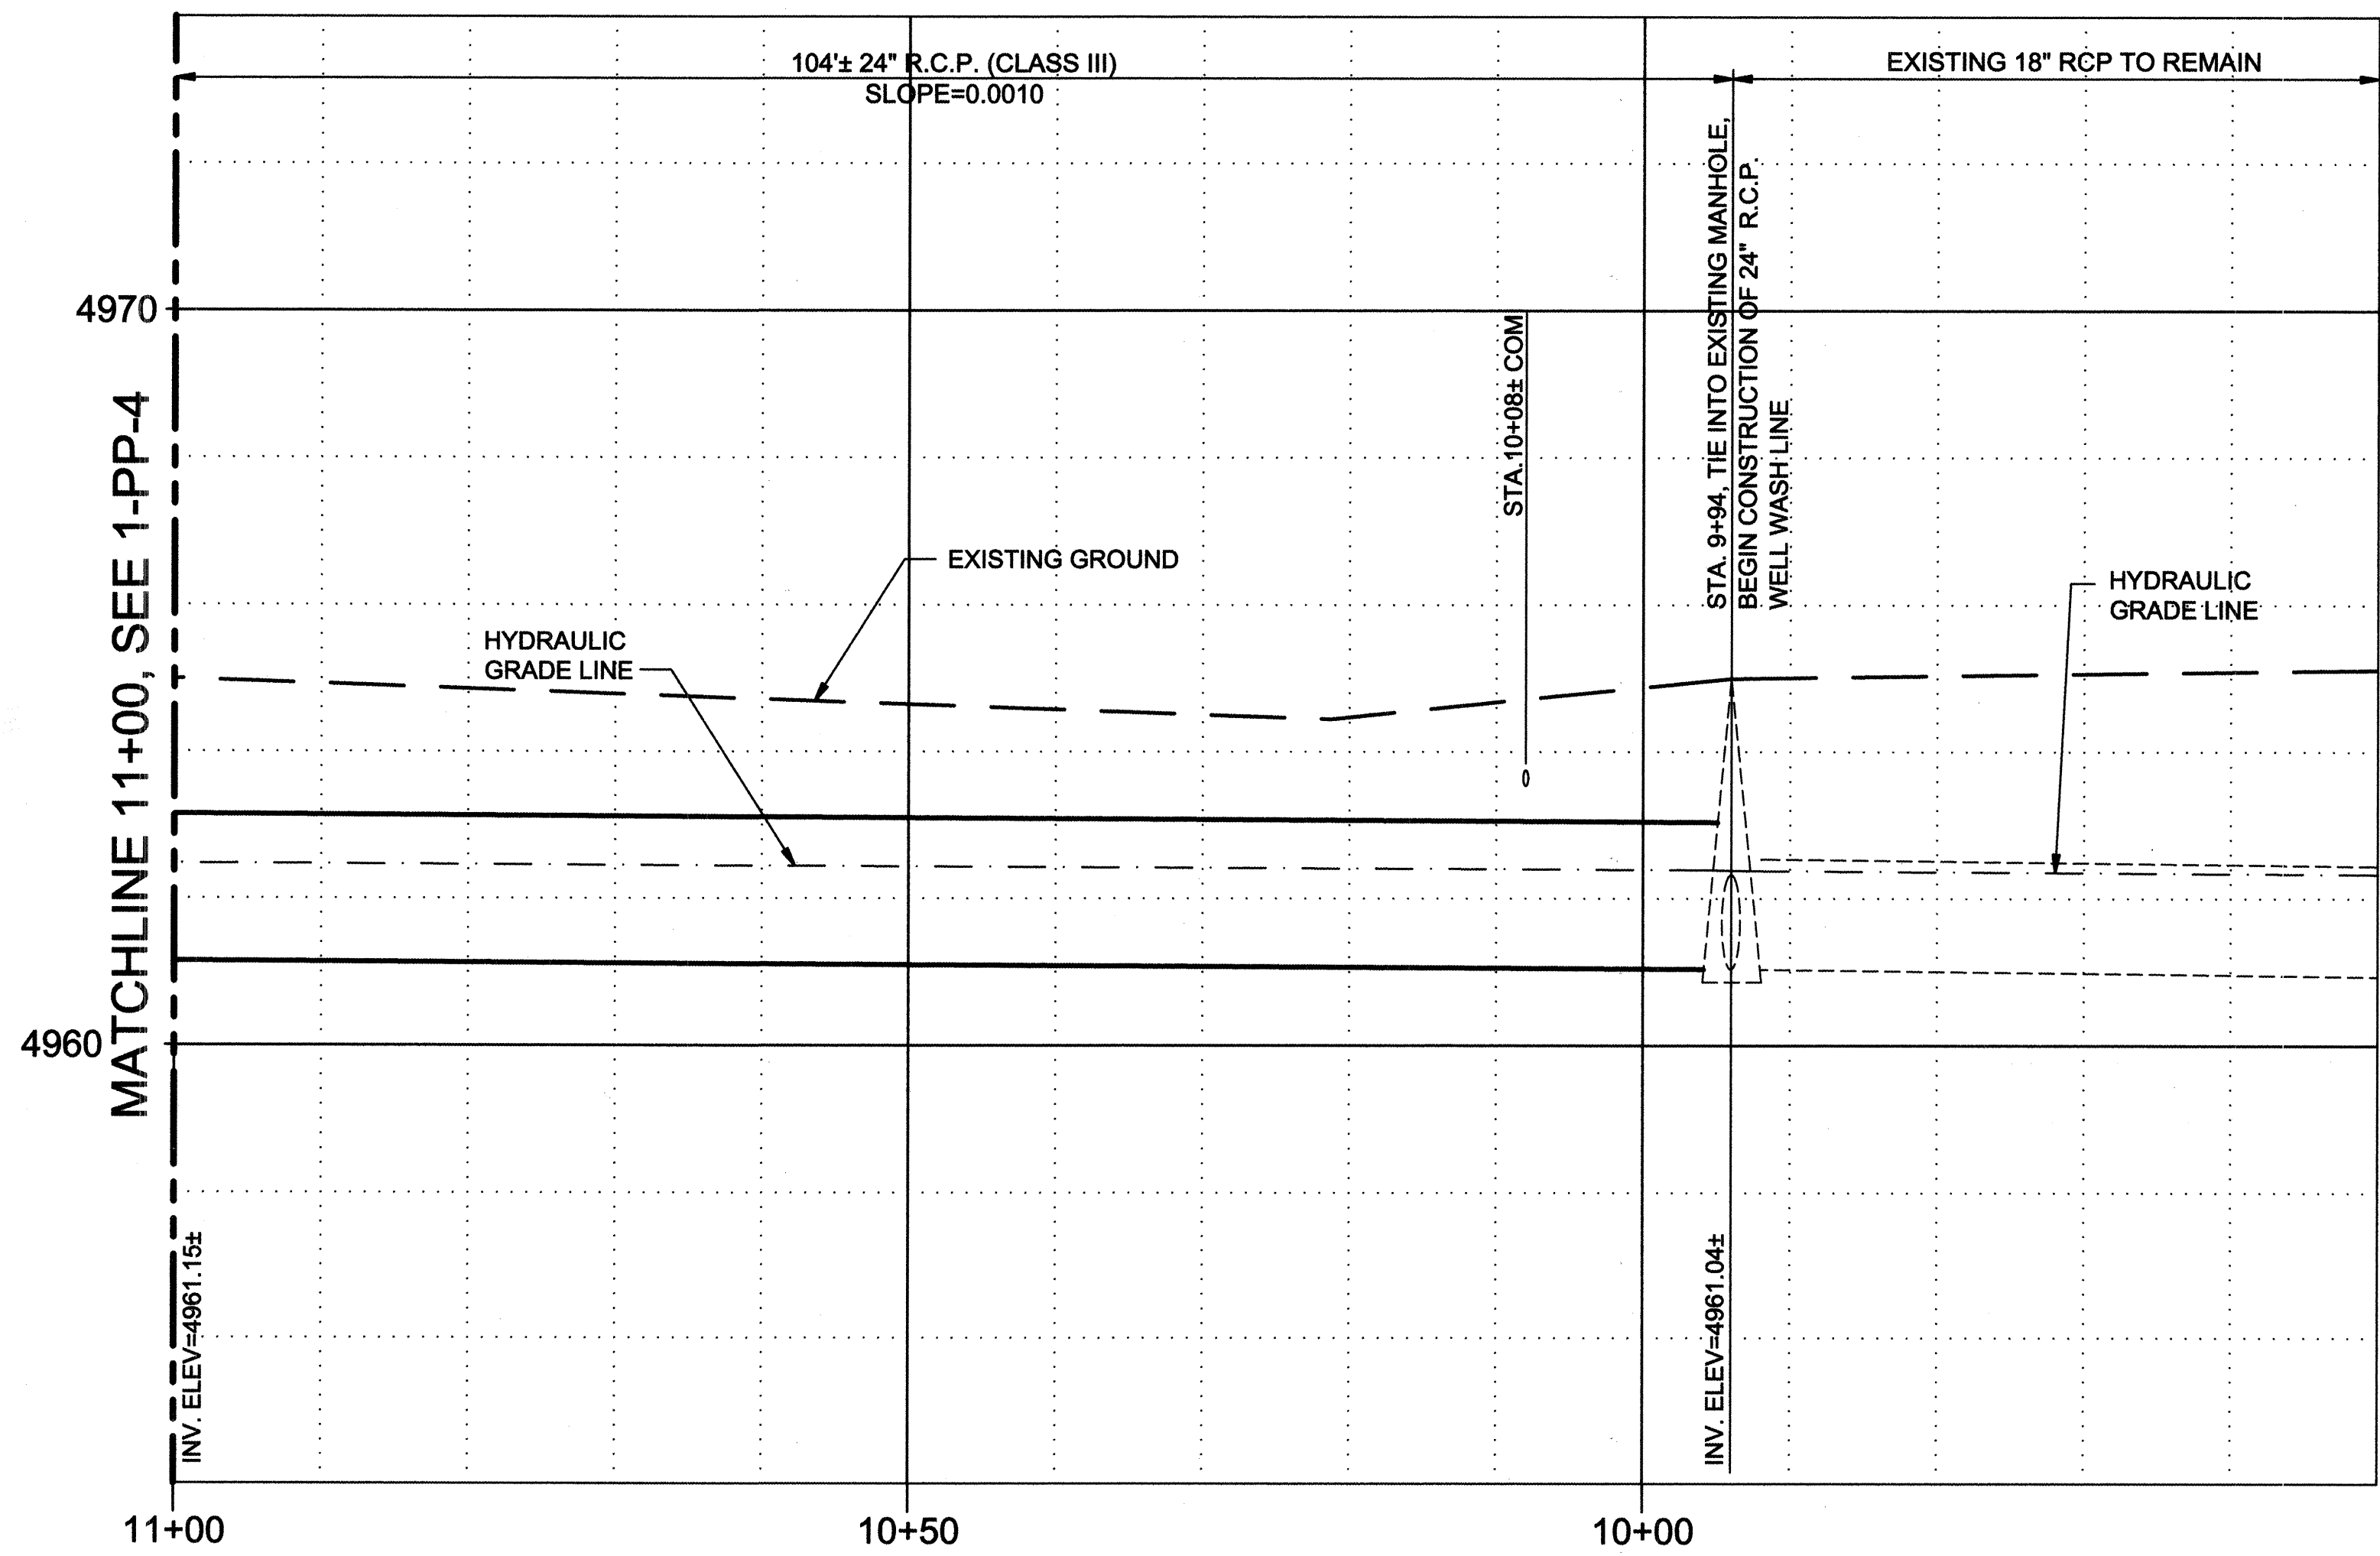

- KEYED NOTES**
- 1 REMOVE, SALVAGE, AND REPLACE WOODEN "THOMAS VILLAGE" SIGN IN AS GOOD OR BETTER CONDITION THAN EXISTING.
 - 2 REPLACE MOUNTABLE CURB AND GUTTER TO MATCH EXISTING, PER COA STD DWG 2415.
 - 3 REMOVE AND REPLACE ASPHALT PAVEMENT PER COA STD DWG 2465. PAVEMENT CUTS MUST BE ORTHOGONAL TO FLOW OF TRAFFIC.
 - 4 PROTECT CONCRETE SIDEWALK DURING CONSTRUCTION.

RECORD DRAWINGS

Revisions Drawn by: EJA Date: 07/20/05

THESE RECORD DRAWINGS HAVE BEEN PREPARED, IN PART, ON THE BASIS OF INFORMATION COMPILED BY OTHERS. THEY ARE NOT INTENDED TO REPRESENT IN DETAIL THE EXACT LOCATION, TYPE OF COMPONENT NOR MANNER OF CONSTRUCTION. THE ENGINEER WILL NOT BE RESPONSIBLE FOR ANY ERRORS OR OMISSIONS WHICH HAVE BEEN INCORPORATED INTO THE RECORD DRAWINGS.

SCALE: HORIZONTAL: 1"=10'
VERTICAL: 1"=2'

CH2MHILL
6001 Indian School Rd, N.E., SUITE 350
Albuquerque, New Mexico 87110
(505) 884-5600


Albuquerque Bernalillo County
Water Utility Authority


TITLE: DURANES WELLS 2, 3 AND 6 WASHLINE MODIFICATIONS
DURANES WELL #2 WASHLINE - STA. 9+50 TO STA. 11+00

Design Review Committee: **APPROVE** SEP 26 2006
City Engineer Approval: **APPROVE** SEP 26 2006
Last Design Update: **DESIGN REVIEW COMMITTEE** **CITY ENGINEER**



CITY PROJECT NO. **7279-03** Zone Map No. **G-12** SHEET **8** OF **16**
DRAWING NO. **1-PP-5**

ENGINEER'S SEAL										SURVEY INFORMATION				BENCH MARKS				AS BUILT INFORMATION			
										FIELD NOTES				BM#1 LOCATED AT THE INTERSECTION OF RIO GRANDE BLVD. N.W. AND MATTHEW AVE. N.W.				CONTRACTOR: NEW MEXICO UNDERGROUND CONTRACTORS INC.			
																		WORK: TERRA LAND SURVEYS LLC			
						BY		DATE		STATION IS AN ACS BRASS TABLET, STAMPED "3-G12"				FIELD ACCEPTANCE BY: CH2MHILL				DATE: 08/20/07			
										X=373,008.3079 Y=1,499,083.8586 EL.=4,963.29				DRAWINGS BY: CH2MHILL				DATE: 08/20/07			
										BM#2 LOCATED NEAR THE END OF THE CUL-DE-SAC ON SHERIDAN ST. STATION IS USC&GS BRASS TABLET				CORRECTED BY: CH2MHILL				DATE: 08/20/07			
										STAMPED "888-C, NO. 1, ALBUQUERQUE DISTRICT, 1950"				RECORDED BY: MICRO FILM INFORMATION				DATE: 08/20/07			
										X=371,825.0808 Y=1,499,849.6127 EL.=4,967.32				NO.							
										HORIZ: NAD 27, VERT: SLD 29											
Ilo County Authority																					
MODIFICATIONS																					
9+50 TO STA. 11+00																					
Mo./Day/Yr.																					
Mo./Day/Yr.																					

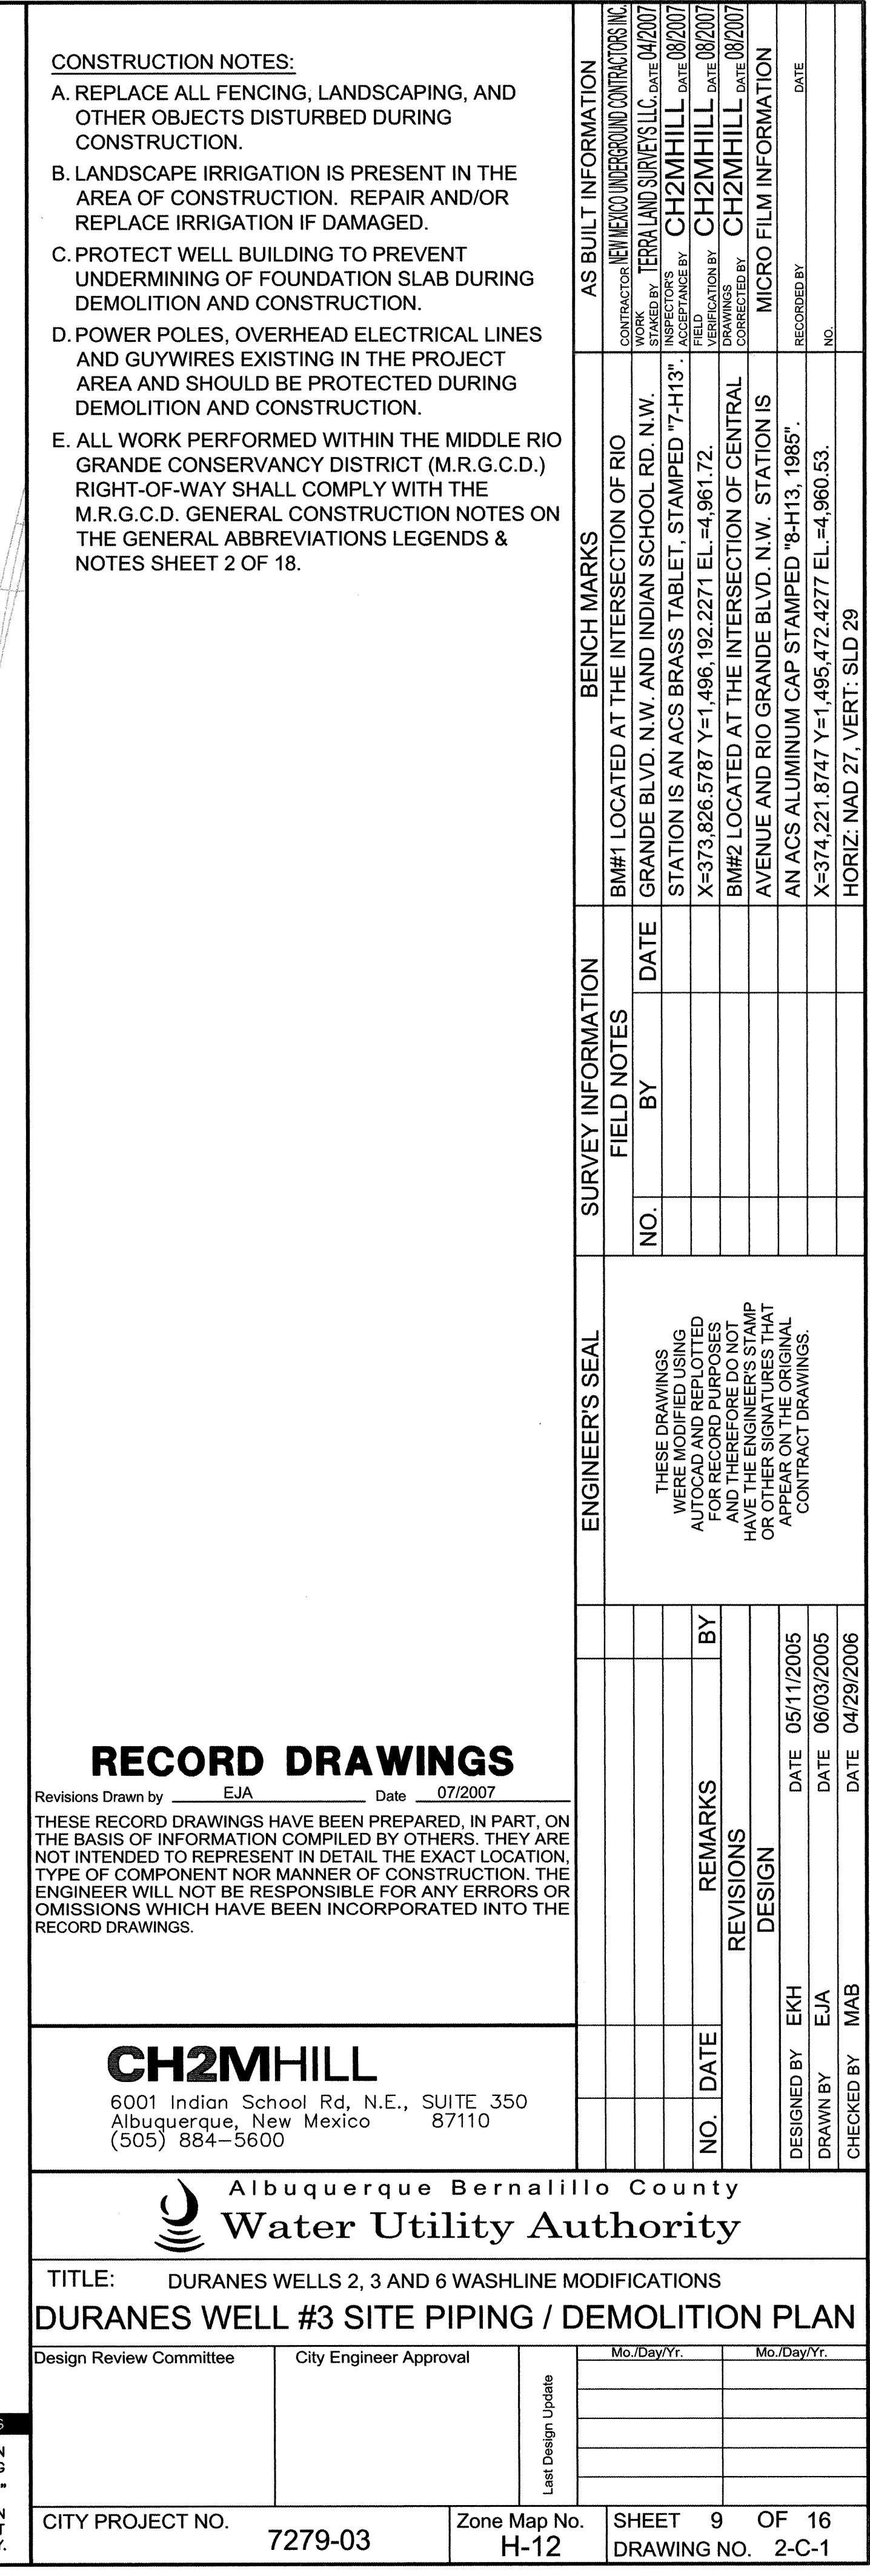

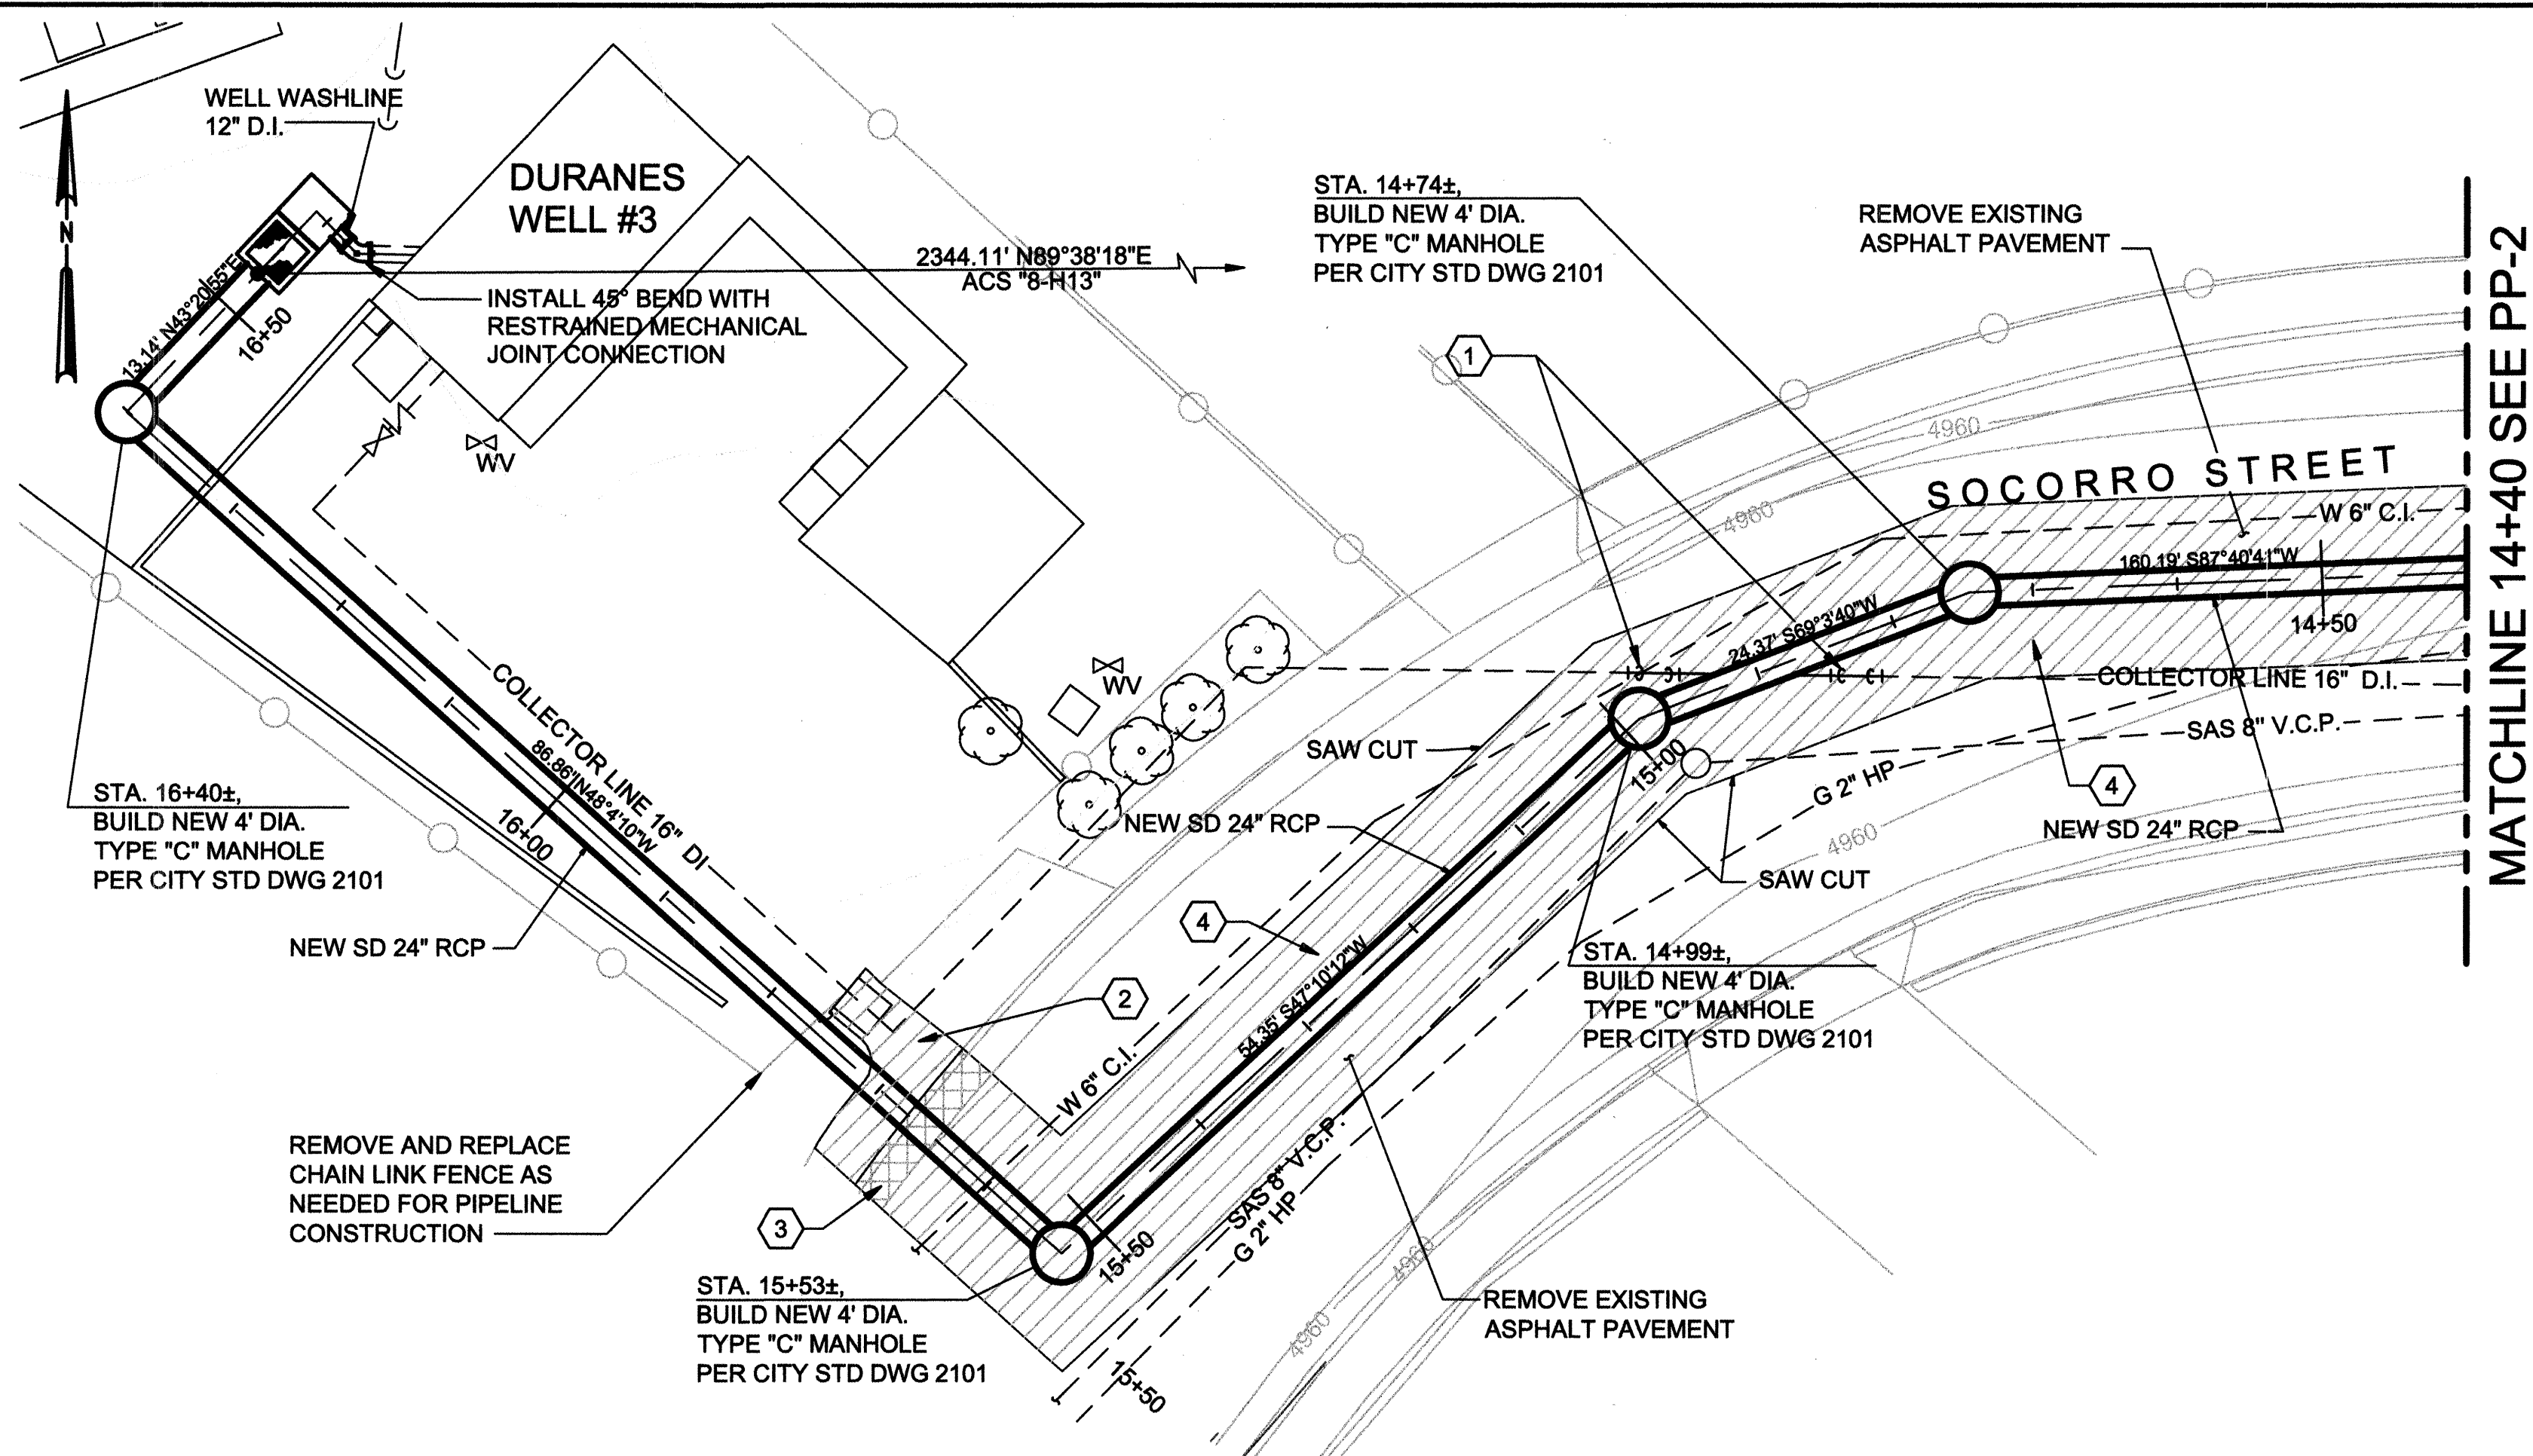

- CONSTRUCTION NOTES:**
 A. CONTACT UTILITY OWNERS IF UTILITIES MUST BE MOVED FOR CONSTRUCTION.
- KEYED NOTES**
- 1 LOWER EXISTING 16" COLLECTOR LINE, SEE 1
 - 2 REMOVE AND REPLACE DRIVEPAD AND SIDEWALK TO MATCH EXISTING.
 - 3 REMOVE AND REPLACE CURB AND GUTTER TO MATCH EXISTING, PER COA STD DWG 2415.
 - 4 REMOVE AND REPLACE ASPHALT PAVEMENT PER COA STD DWG 2465. PAVEMENT CUTS MUST BE ORTHOGONAL TO FLOW OF TRAFFIC.

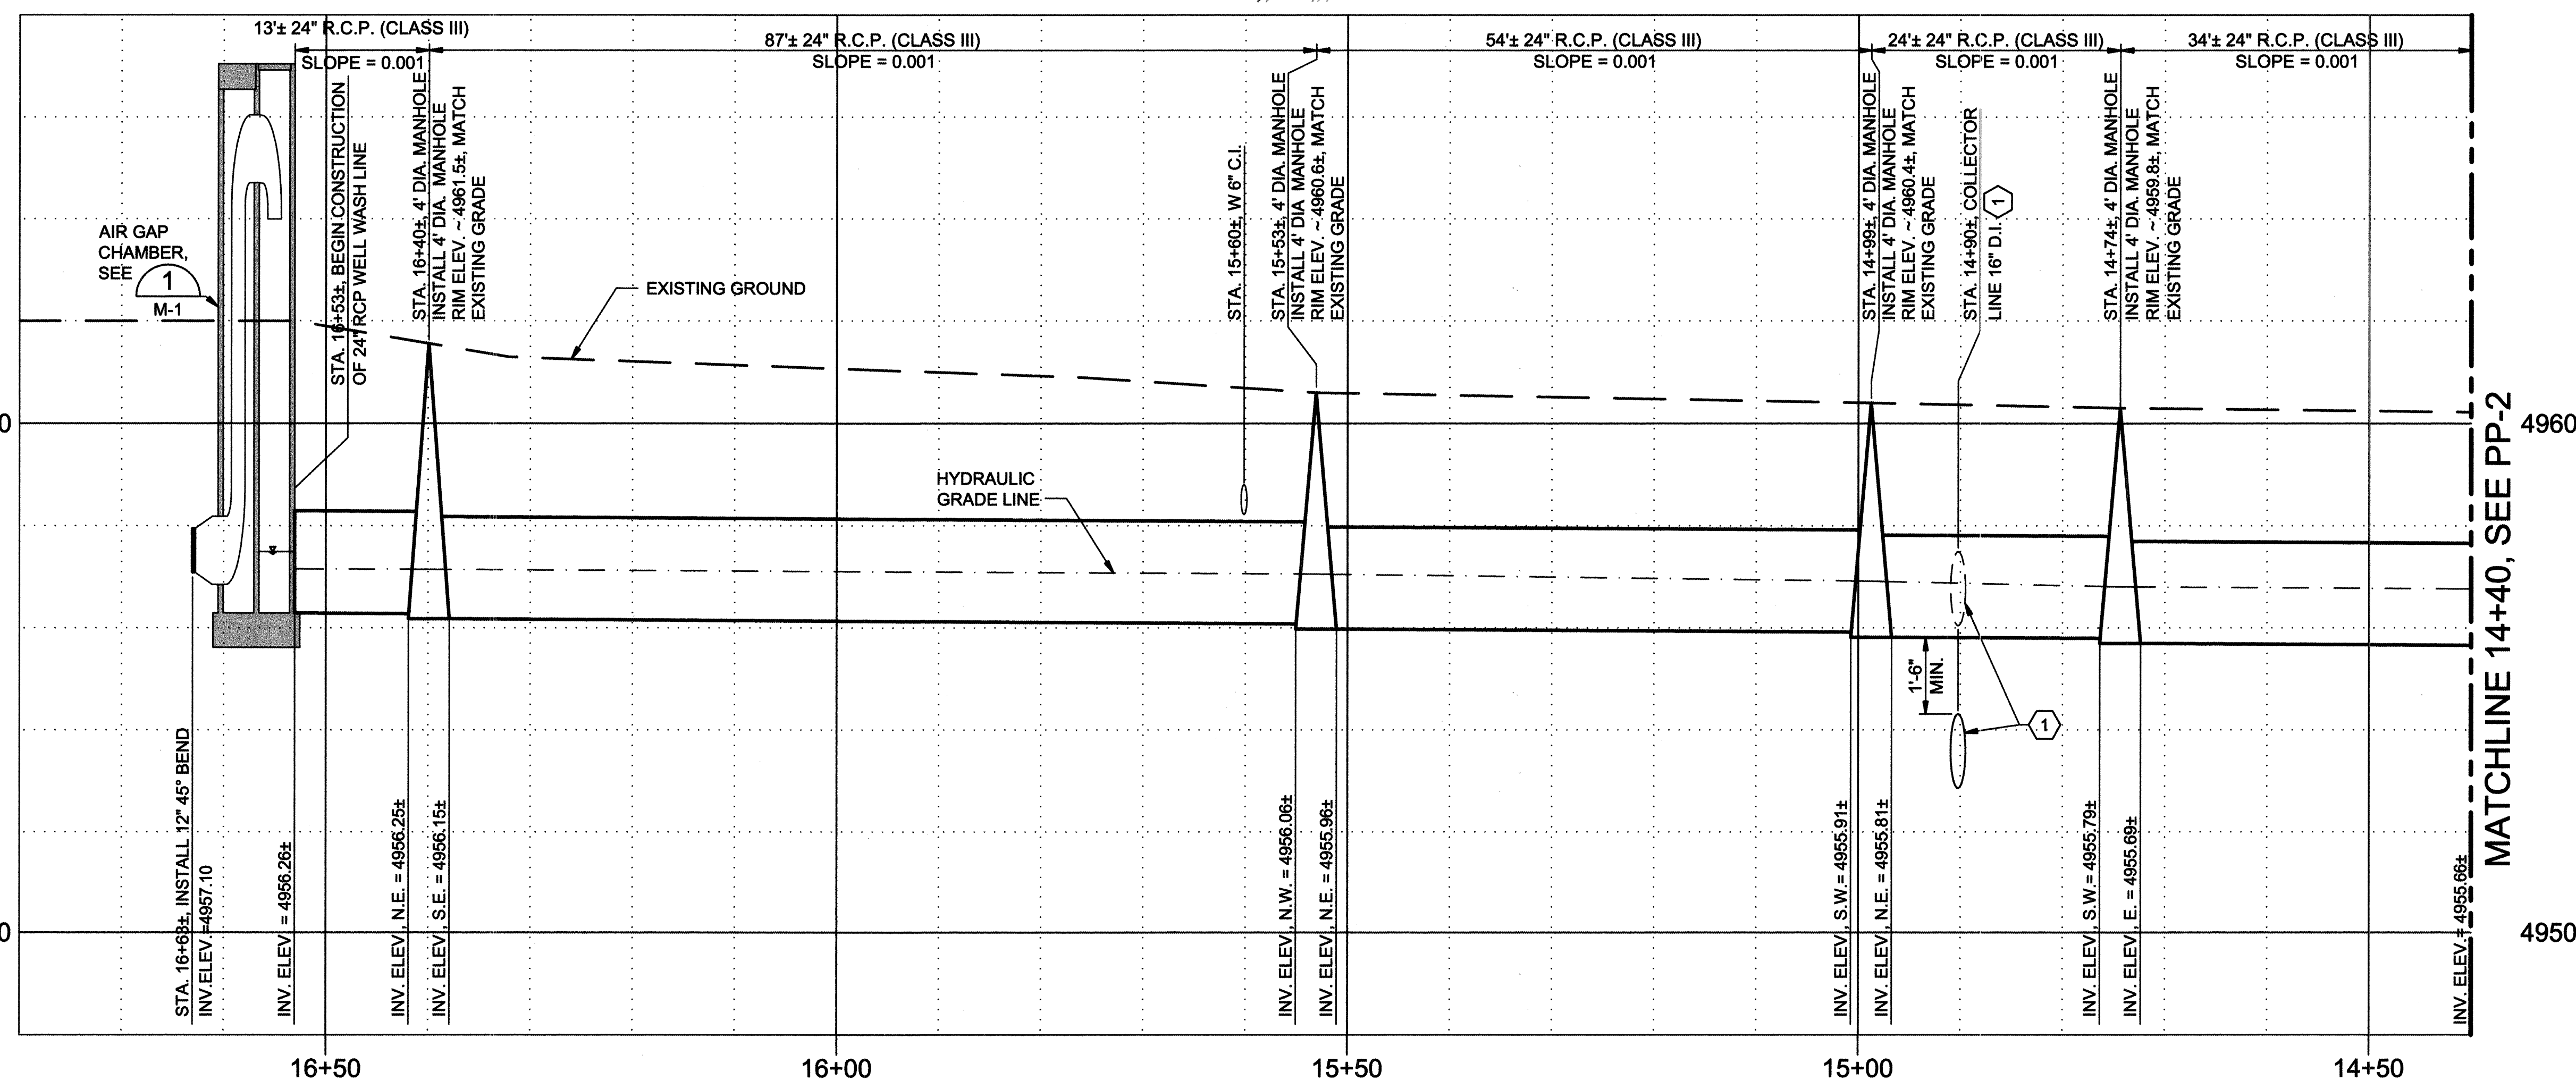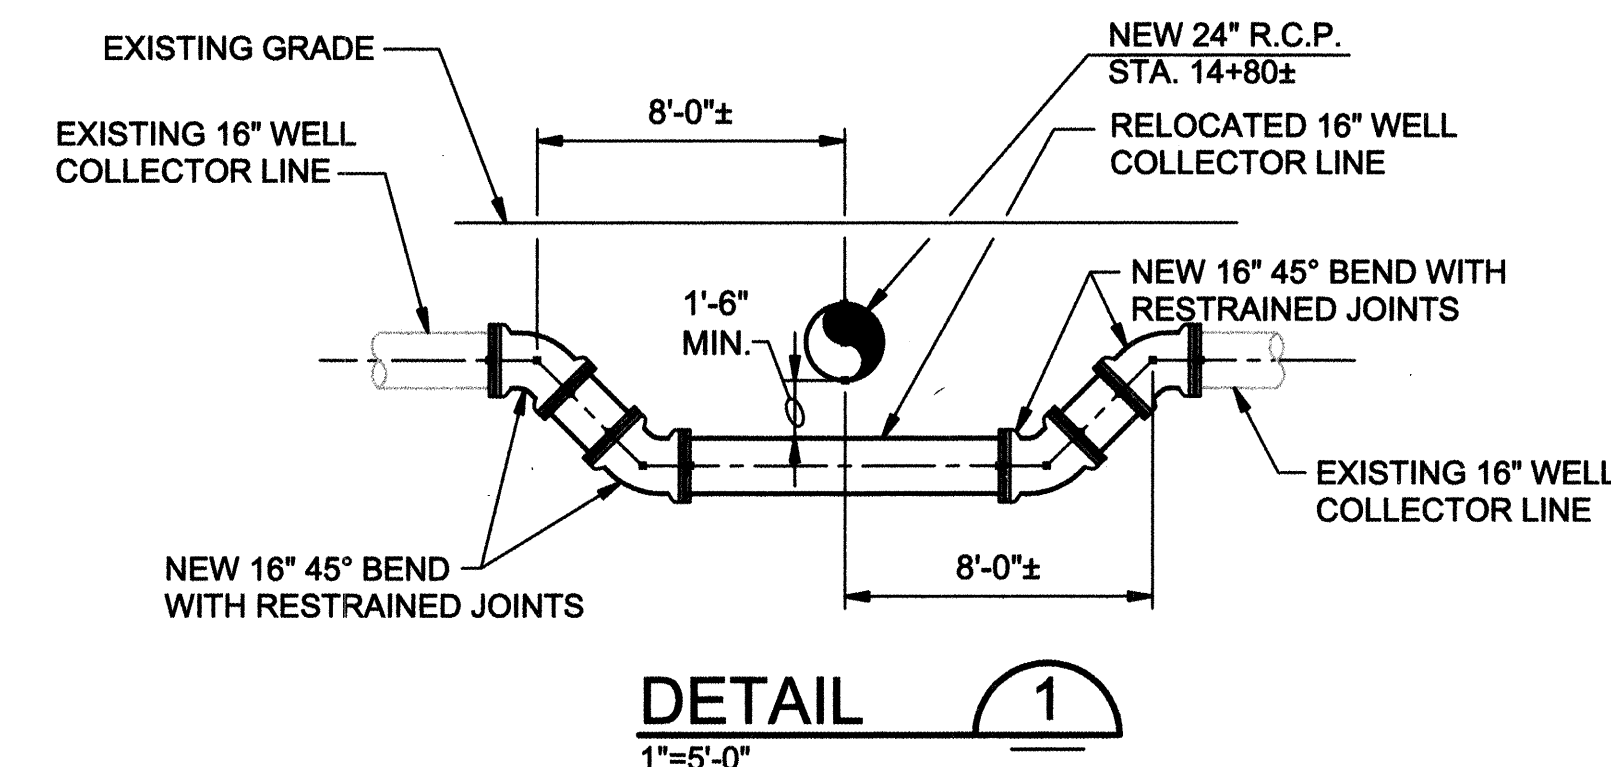

MATCHLINE 14+40, SEE PP-2

MATCHLINE 14+40, SEE PP-2

THIS SHEET SUPERSEDED BY
 SIMILAR SHEET MARKED
 "RECORD DRAWING"

SCALE: HORIZONTAL: 1"=10'
 VERTICAL: 1"=2'

CH2MHILL

6001 Indian School Rd, N.E., SUITE 350
 Albuquerque, New Mexico 87110
 (505) 884-5600


Albuquerque Bernalillo County
Water Utility Authority

TITLE: DURANES WELLS 2, 3 AND 6 WASHLINE MODIFICATIONS
DURANES WELL #3 WASH LINE - STA. 14+40 TO STA. 16+63


Design Review Committee SEP 26 2006 DESIGN REVIEW COMMITTEE	City Engineer Approval SEP 26 2006 CITY ENGINEER	Mo./Day/Yr. Mo./Day/Yr.
---	--	----------------------------

CITY PROJECT NO. 7279-03 Zone Map No. H-12 SHEET 10 OF 16
 DRAWING NO. 2-PP-1

AS BUILT INFORMATION		BENCH MARKS		SURVEY INFORMATION		ENGINEER'S SEAL	
CONTRACTOR	WORK	BM#1	LOCATED AT	FIELD NOTES	DATE	NO.	BY
NEW MEXICO UNDERGROUND CONTRACTORS INC.	GRANDE BLVD. N.W. AND INDIAN SCHOOL RD. N.W.	BM#1	LOCATED AT THE INTERSECTION OF RIO GRANDE BLVD. N.W. AND INDIAN SCHOOL RD. N.W.				
DATE 04/20/07	STATION IS AN ACS BRASS TABLET, STAMPED "7-H13"						
DATE 08/20/07	X=373.826, Y=1,496.192, 2271 EL.=4,961.72						
DATE 08/20/07	BM#2 LOCATED AT THE INTERSECTION OF CENTRAL AVENUE AND RIO GRANDE BLVD. N.W. STATION IS AN ACS ALUMINUM CAP STAMPED "8-H13, 1985"						
DATE 08/20/07	X=374.221, 8747 Y=1,495.472, 4277 EL.=4,960.53						
DATE 08/20/07	HORIZ. NAD 27, VERT. SLD 29						

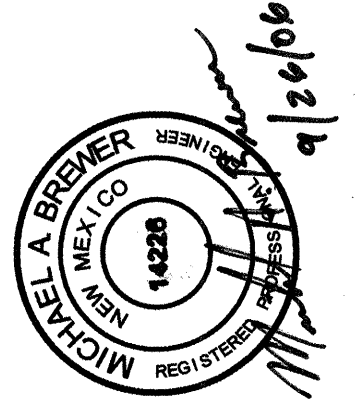

NO.	DATE	REVISIONS	BY
1	05/11/2005	DESIGN	LH
2	06/03/2005		EJA
3	04/29/2006		MAB

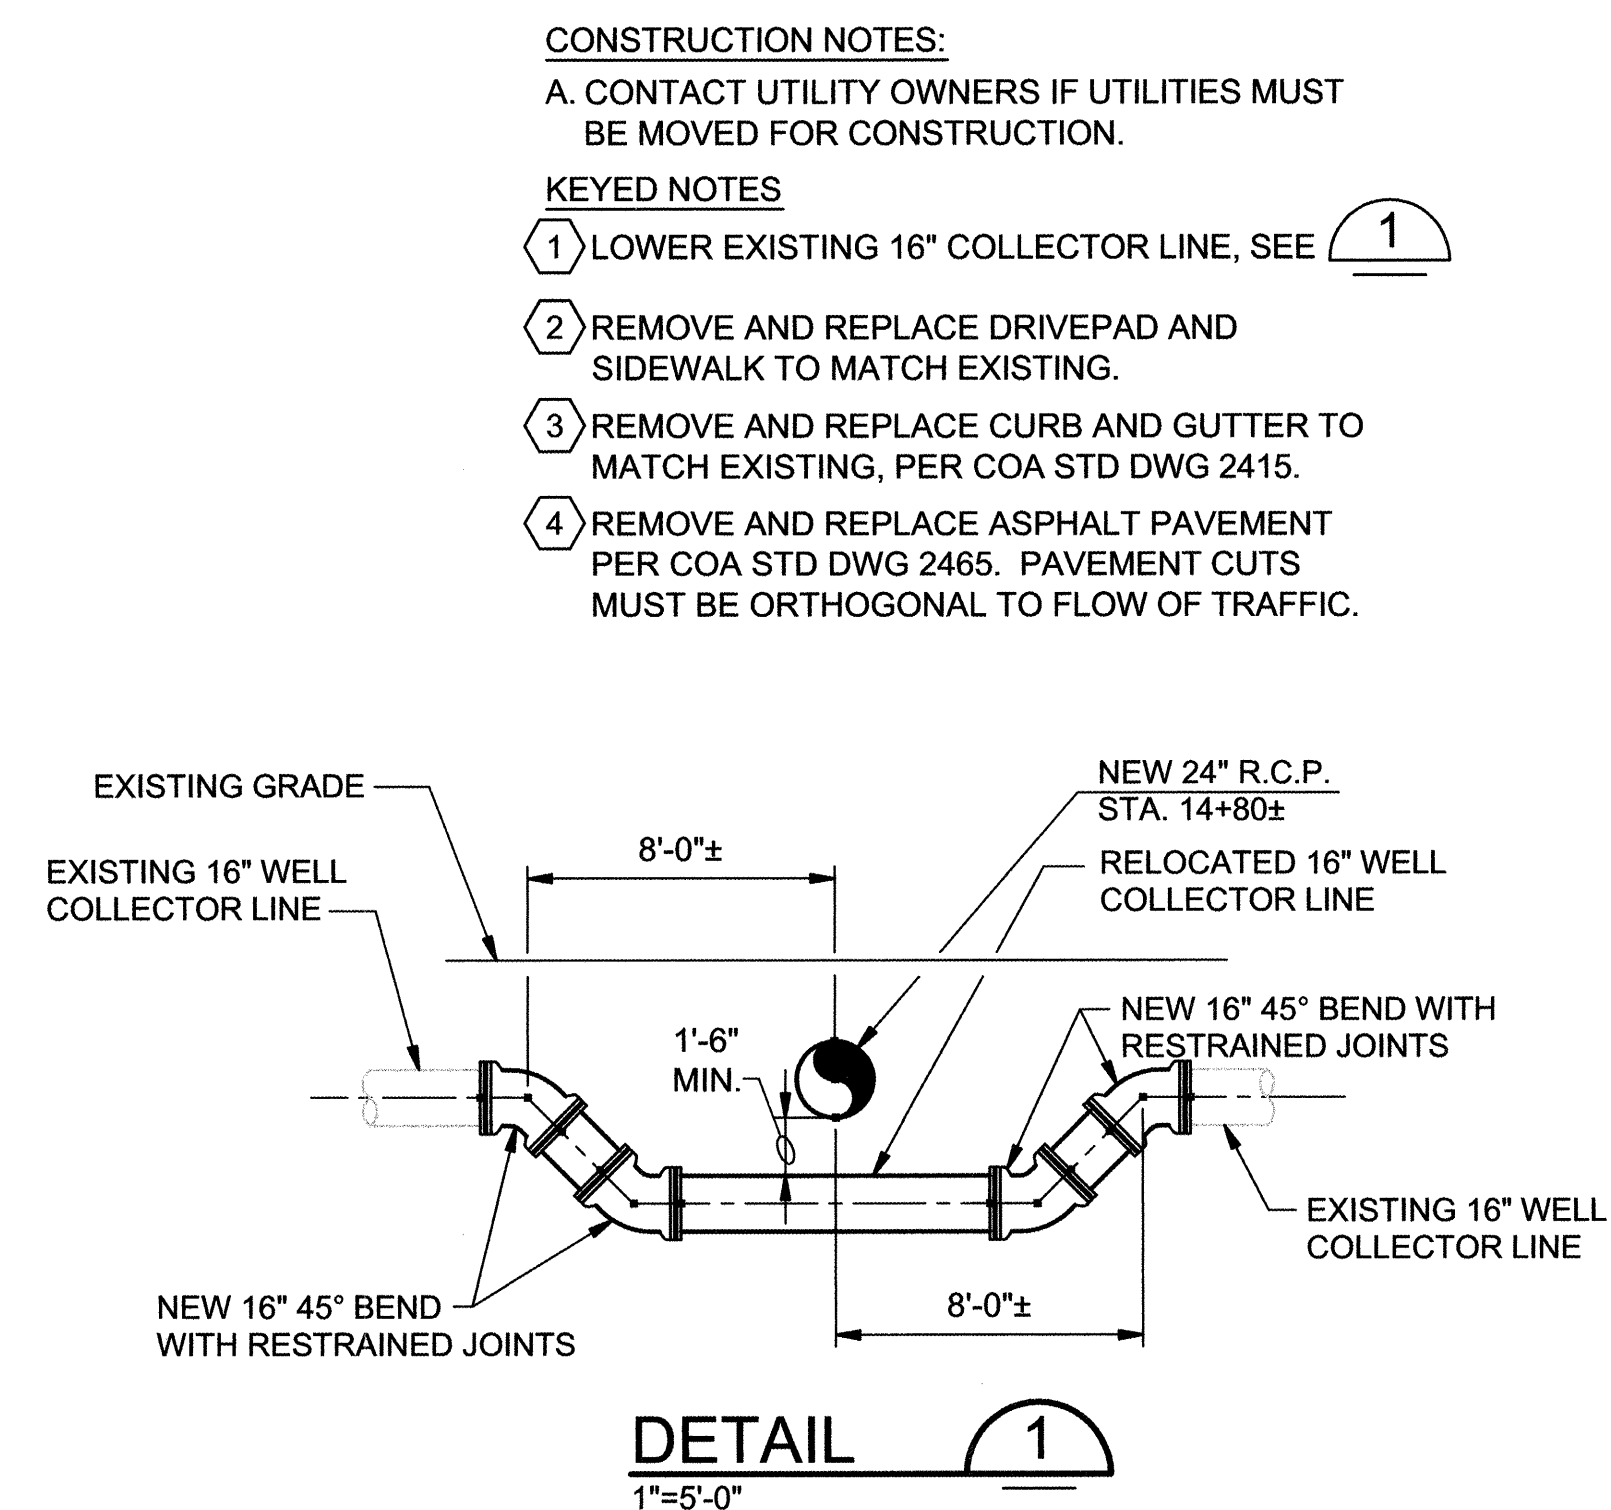

Revisions Drawn by EJA Date 07/2007

THESE RECORD DRAWINGS HAVE BEEN PREPARED, IN PART, ON THE BASIS OF INFORMATION COMPILED BY OTHERS. THEY ARE NOT INTENDED TO REPRESENT IN DETAIL THE EXACT LOCATION, TYPE OF COMPONENT NOR MANNER OF CONSTRUCTION. THE ENGINEER WILL NOT BE RESPONSIBLE FOR ANY ERRORS OF OMISSIONS WHICH HAVE BEEN INCORPORATED INTO THE RECORD DRAWINGS.

SCALE: HORIZONTAL: 1"=10'
VERTICAL 1"=2'

CH2MHILL

6001 Indian School Rd, N.E., SUITE 350
Albuquerque, New Mexico 87110
(505) 884-5600


 Albuquerque Bernalillo County
Water Utility Authority

TITLE: DURANES WELLS 2, 3 AND 6 WASHLINE MODIFICATIONS
DURANES WELL #3 WASH LINE - STA. 14+40 TO STA. 16+63




Design Review Committee	City Engineer Approval	Last Design Update	Mo./Day/Yr.	Mo./Day/Yr.

CITY PROJECT NO.	7279-03	Zone Map No.	SHEET 10 OF 16
		H-12	DRAWING NO. 2-PP-1

323454.BD.DP
323454_3-PP-01.d
1=1
06/06/2007

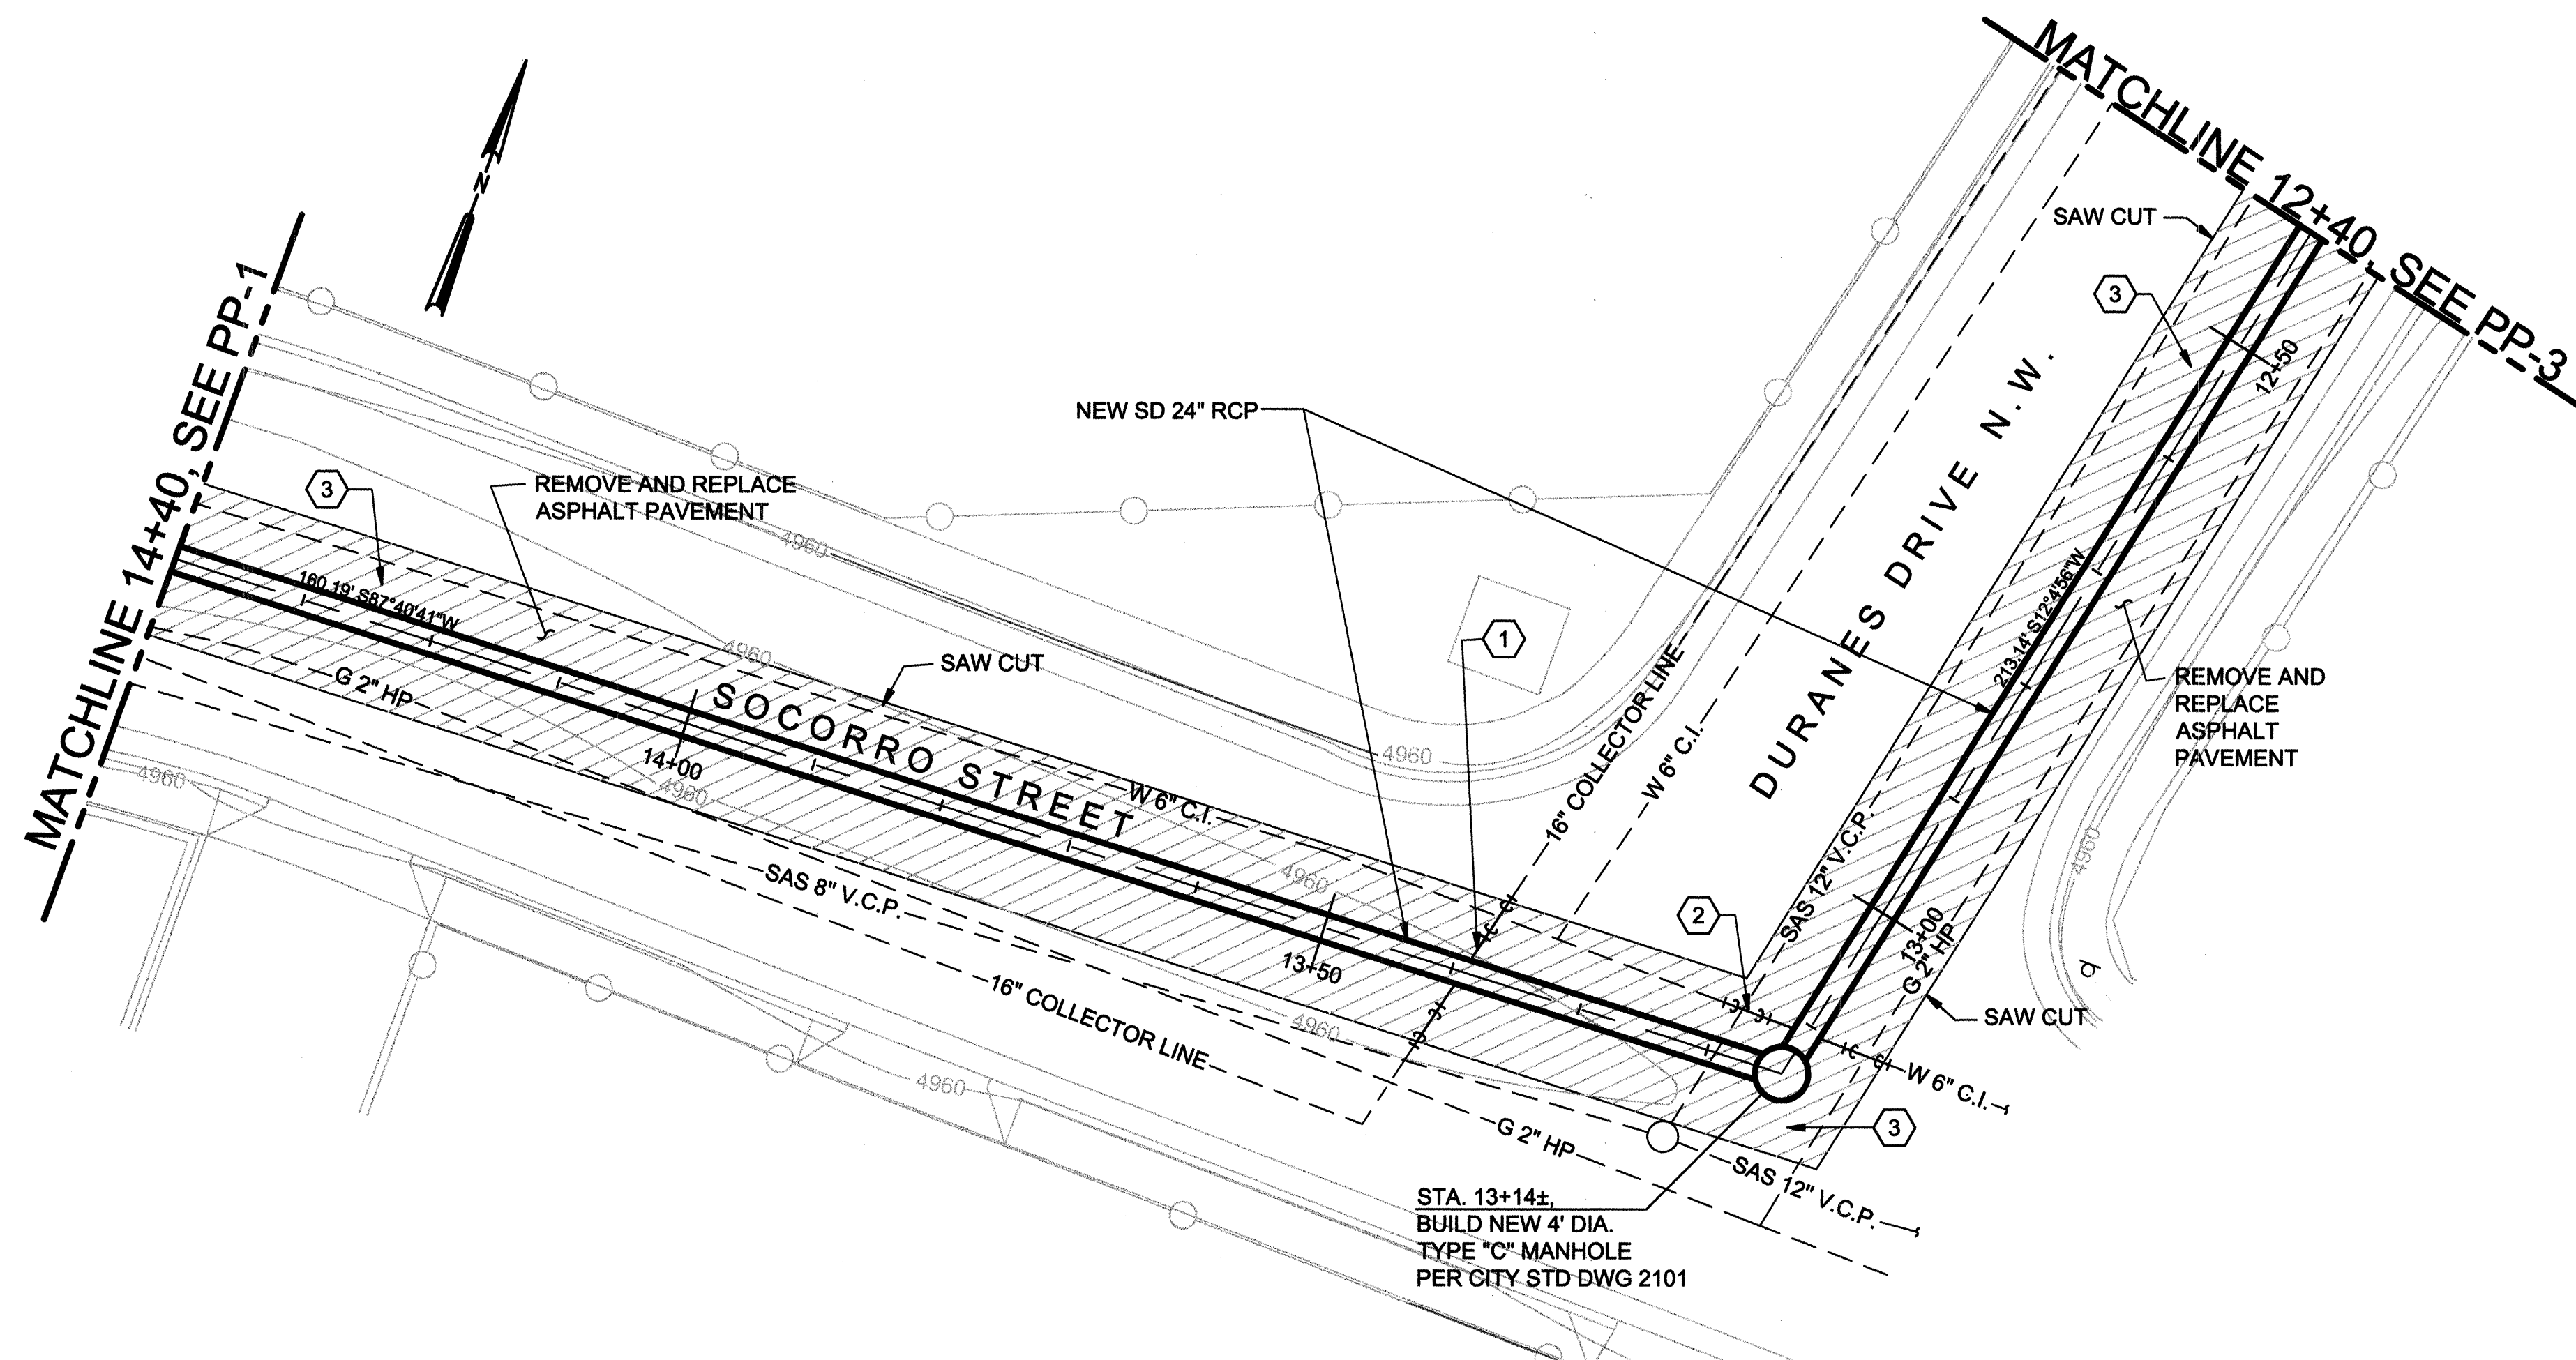

- KEYED NOTES**
- ① LOWER EXISTING 16" COLLECTOR LINE, SEE ①
 - ② LOWER EXISTING 6" WATER LINE, SEE ②
 - ③ REMOVE AND REPLACE ASPHALT PAVEMENT PER COA STD DWG 2465. PAVEMENT CUTS MUST BE ORTHOGONAL TO FLOW OF TRAFFIC.

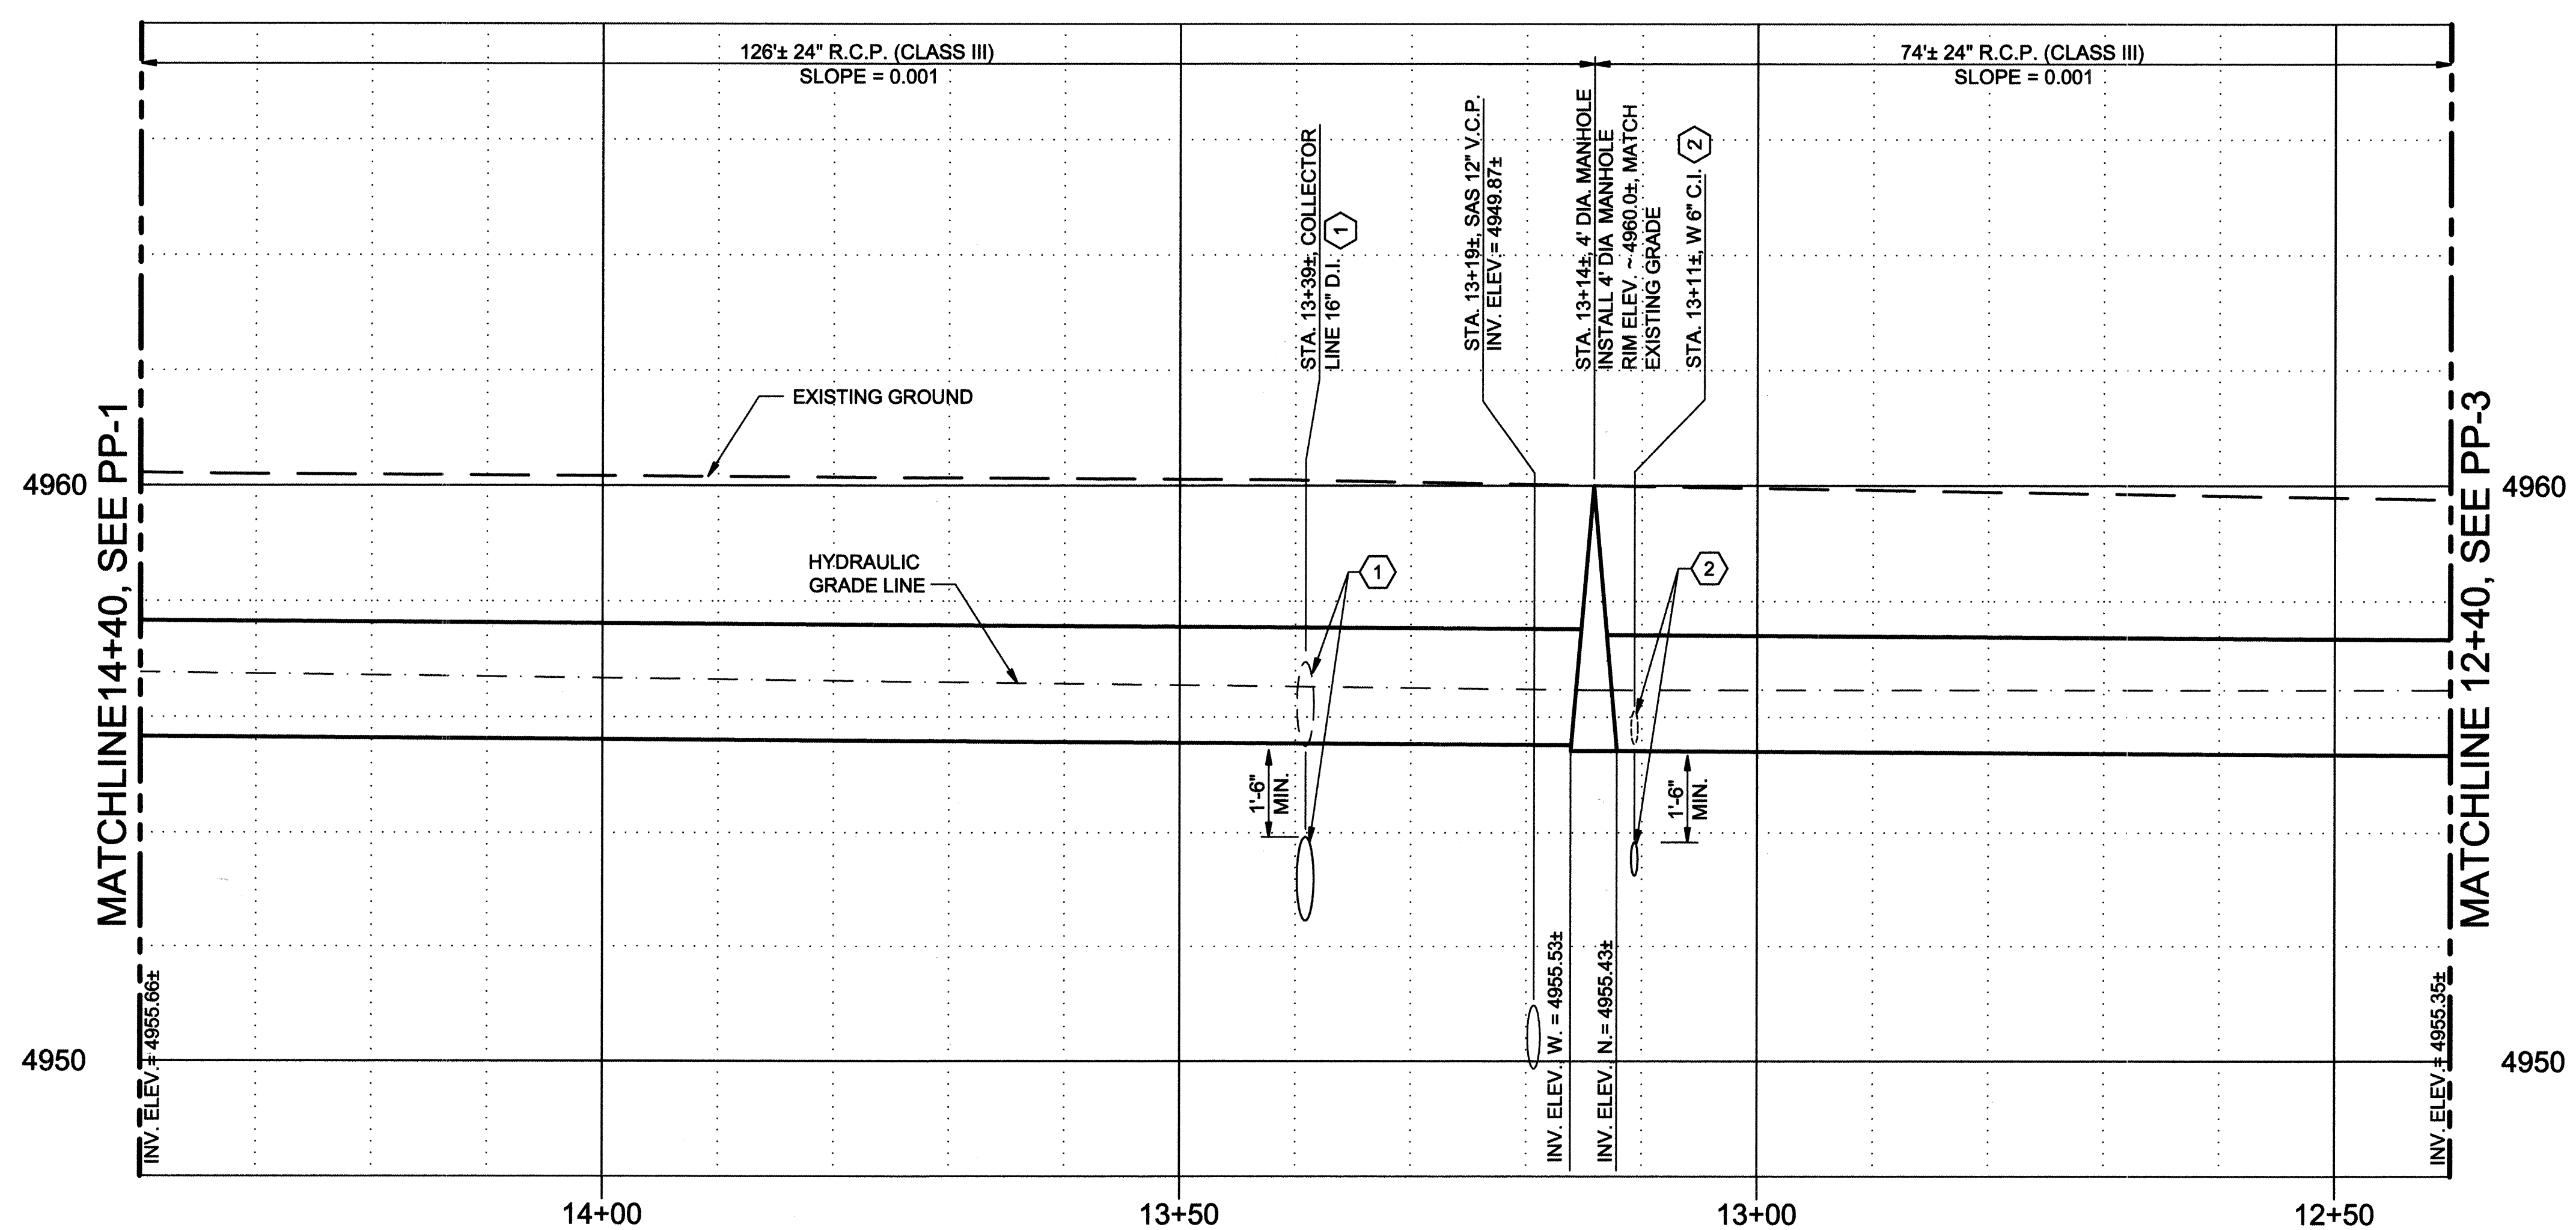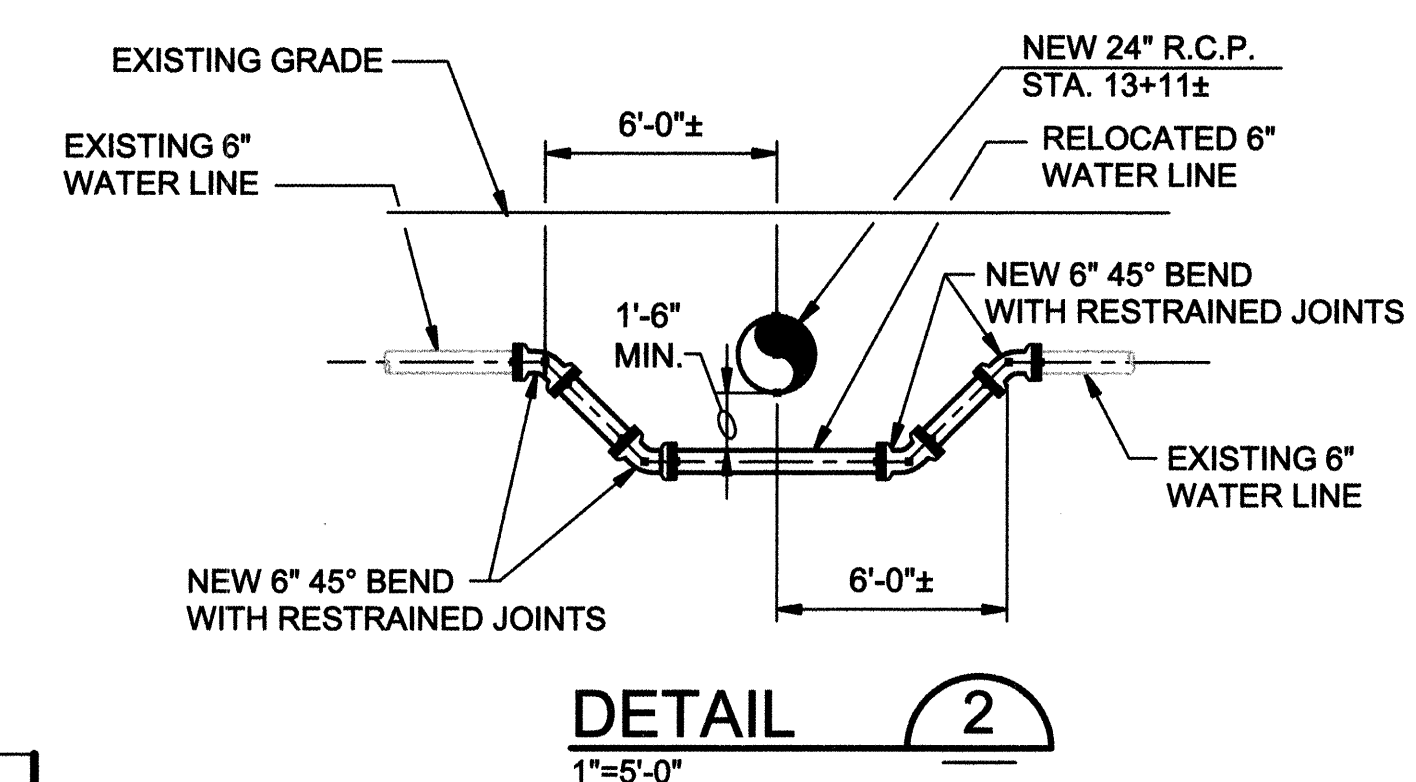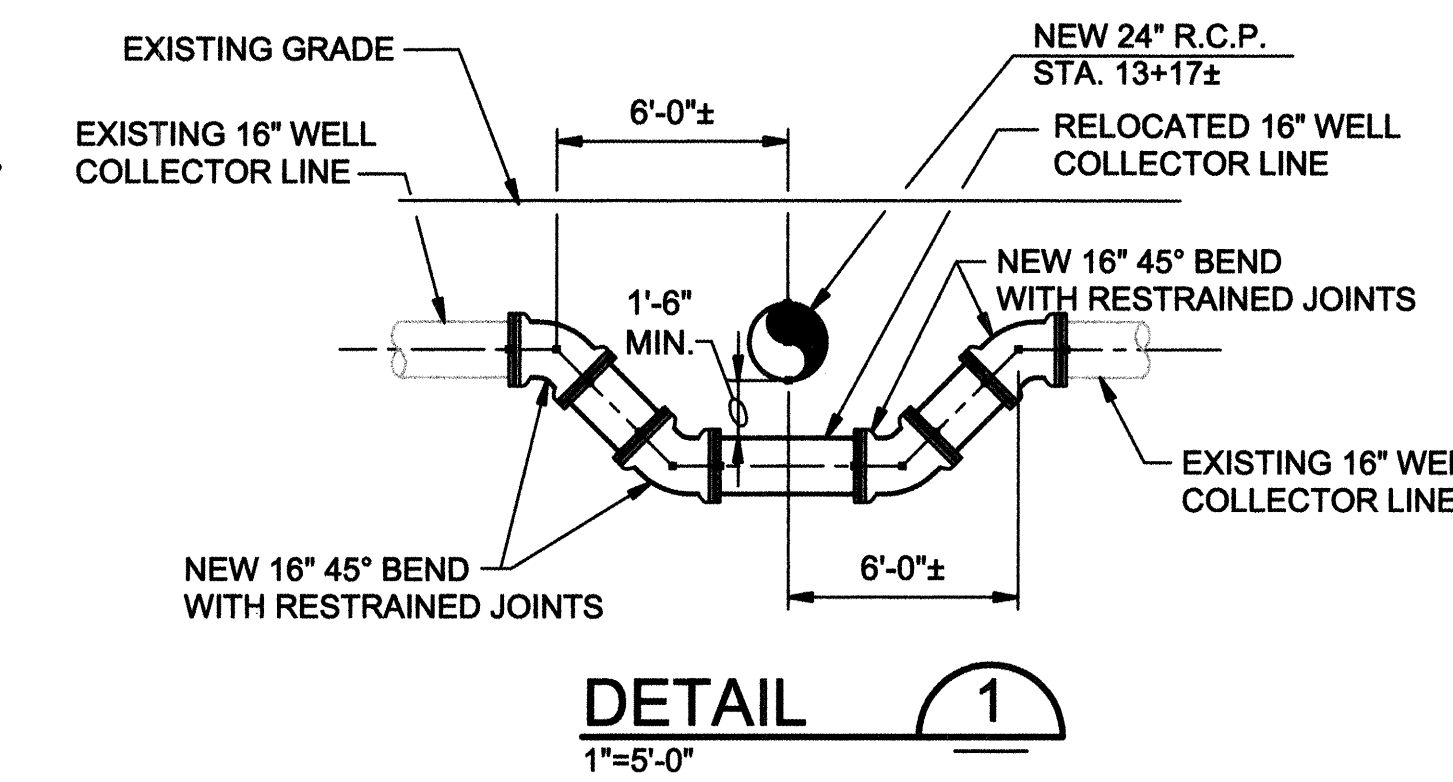

VERIFY SCALES
BAR IS ONE INCH ON ORIGINAL DRAWING
0" = 1"
IF NOT ONE INCH ON THIS SHEET, ADJUST SCALES ACCORDINGLY.

**THIS SHEET SUPERSEDED BY
SIMILAR SHEET MARKED
"RECORD DRAWING"**

SCALE: HORIZONTAL: 1"=10'
VERTICAL: 1"=2'


CH2MHILL
6001 Indian School Rd, N.E., SUITE 350
Albuquerque, New Mexico 87110
(505) 884-5600


**Albuquerque Bernalillo County
Water Utility Authority**

TITLE: DURANES WELLS 2, 3 AND 6 WASHLINE MODIFICATIONS
DURANES WELL #3 WASH LINE - STA. 12+40 TO STA. 14+40




DESIGNED BY	LH	DATE	05/11/2005
DRAWN BY	EJA	DATE	06/03/2005
CHECKED BY	MAB	DATE	04/29/2006

CITY PROJECT NO. 7279-03 Zone Map No. H-12 SHEET 11 OF 16 DRAWING NO. 2-PP-2

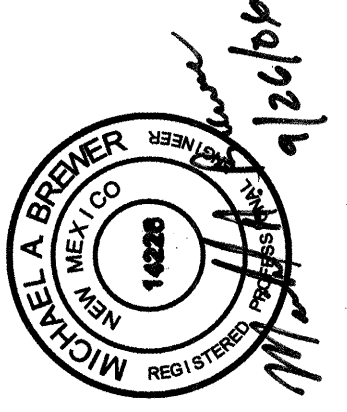AS BUILT INFORMATION		BENCH MARKS		SURVEY INFORMATION		ENGINEER'S SEAL	
CONTRACTOR	NEW MEXICO UNDERGROUND CONTRACTORS, INC.	BM#1	LOCATED AT THE INTERSECTION OF RIO GRANDE BLVD. N.W. AND INDIAN SCHOOL RD. N.W.	NO.	DATE		
STATIONED BY	TERRA LAND SURVEYS, L.L.C. DATE 04/2002		STATION IS AN ACS BRASS TABLET, STAMPED "7-H13"	BY			
ACCEPTANCE BY	CH2MHILL DATE 08/2002		X=373.826, 5787 Y=1,496.192, 2271 EL.=4,961.72				
VERIFICATION BY	CH2MHILL DATE 08/2002		BM#2 LOCATED AT THE INTERSECTION OF CENTRAL AVENUE AND RIO GRANDE BLVD. N.W. STATION IS AN ACS ALUMINUM CAP STAMPED "8-H13, 1985"				
DRAWINGS	CH2MHILL DATE 08/2002						
CORRECTED BY	CH2MHILL DATE 08/2002						
RECORDED BY							
NO.							
MICRO FILM INFORMATION				HORIZ: NAD 27, VERT: SLD 29			

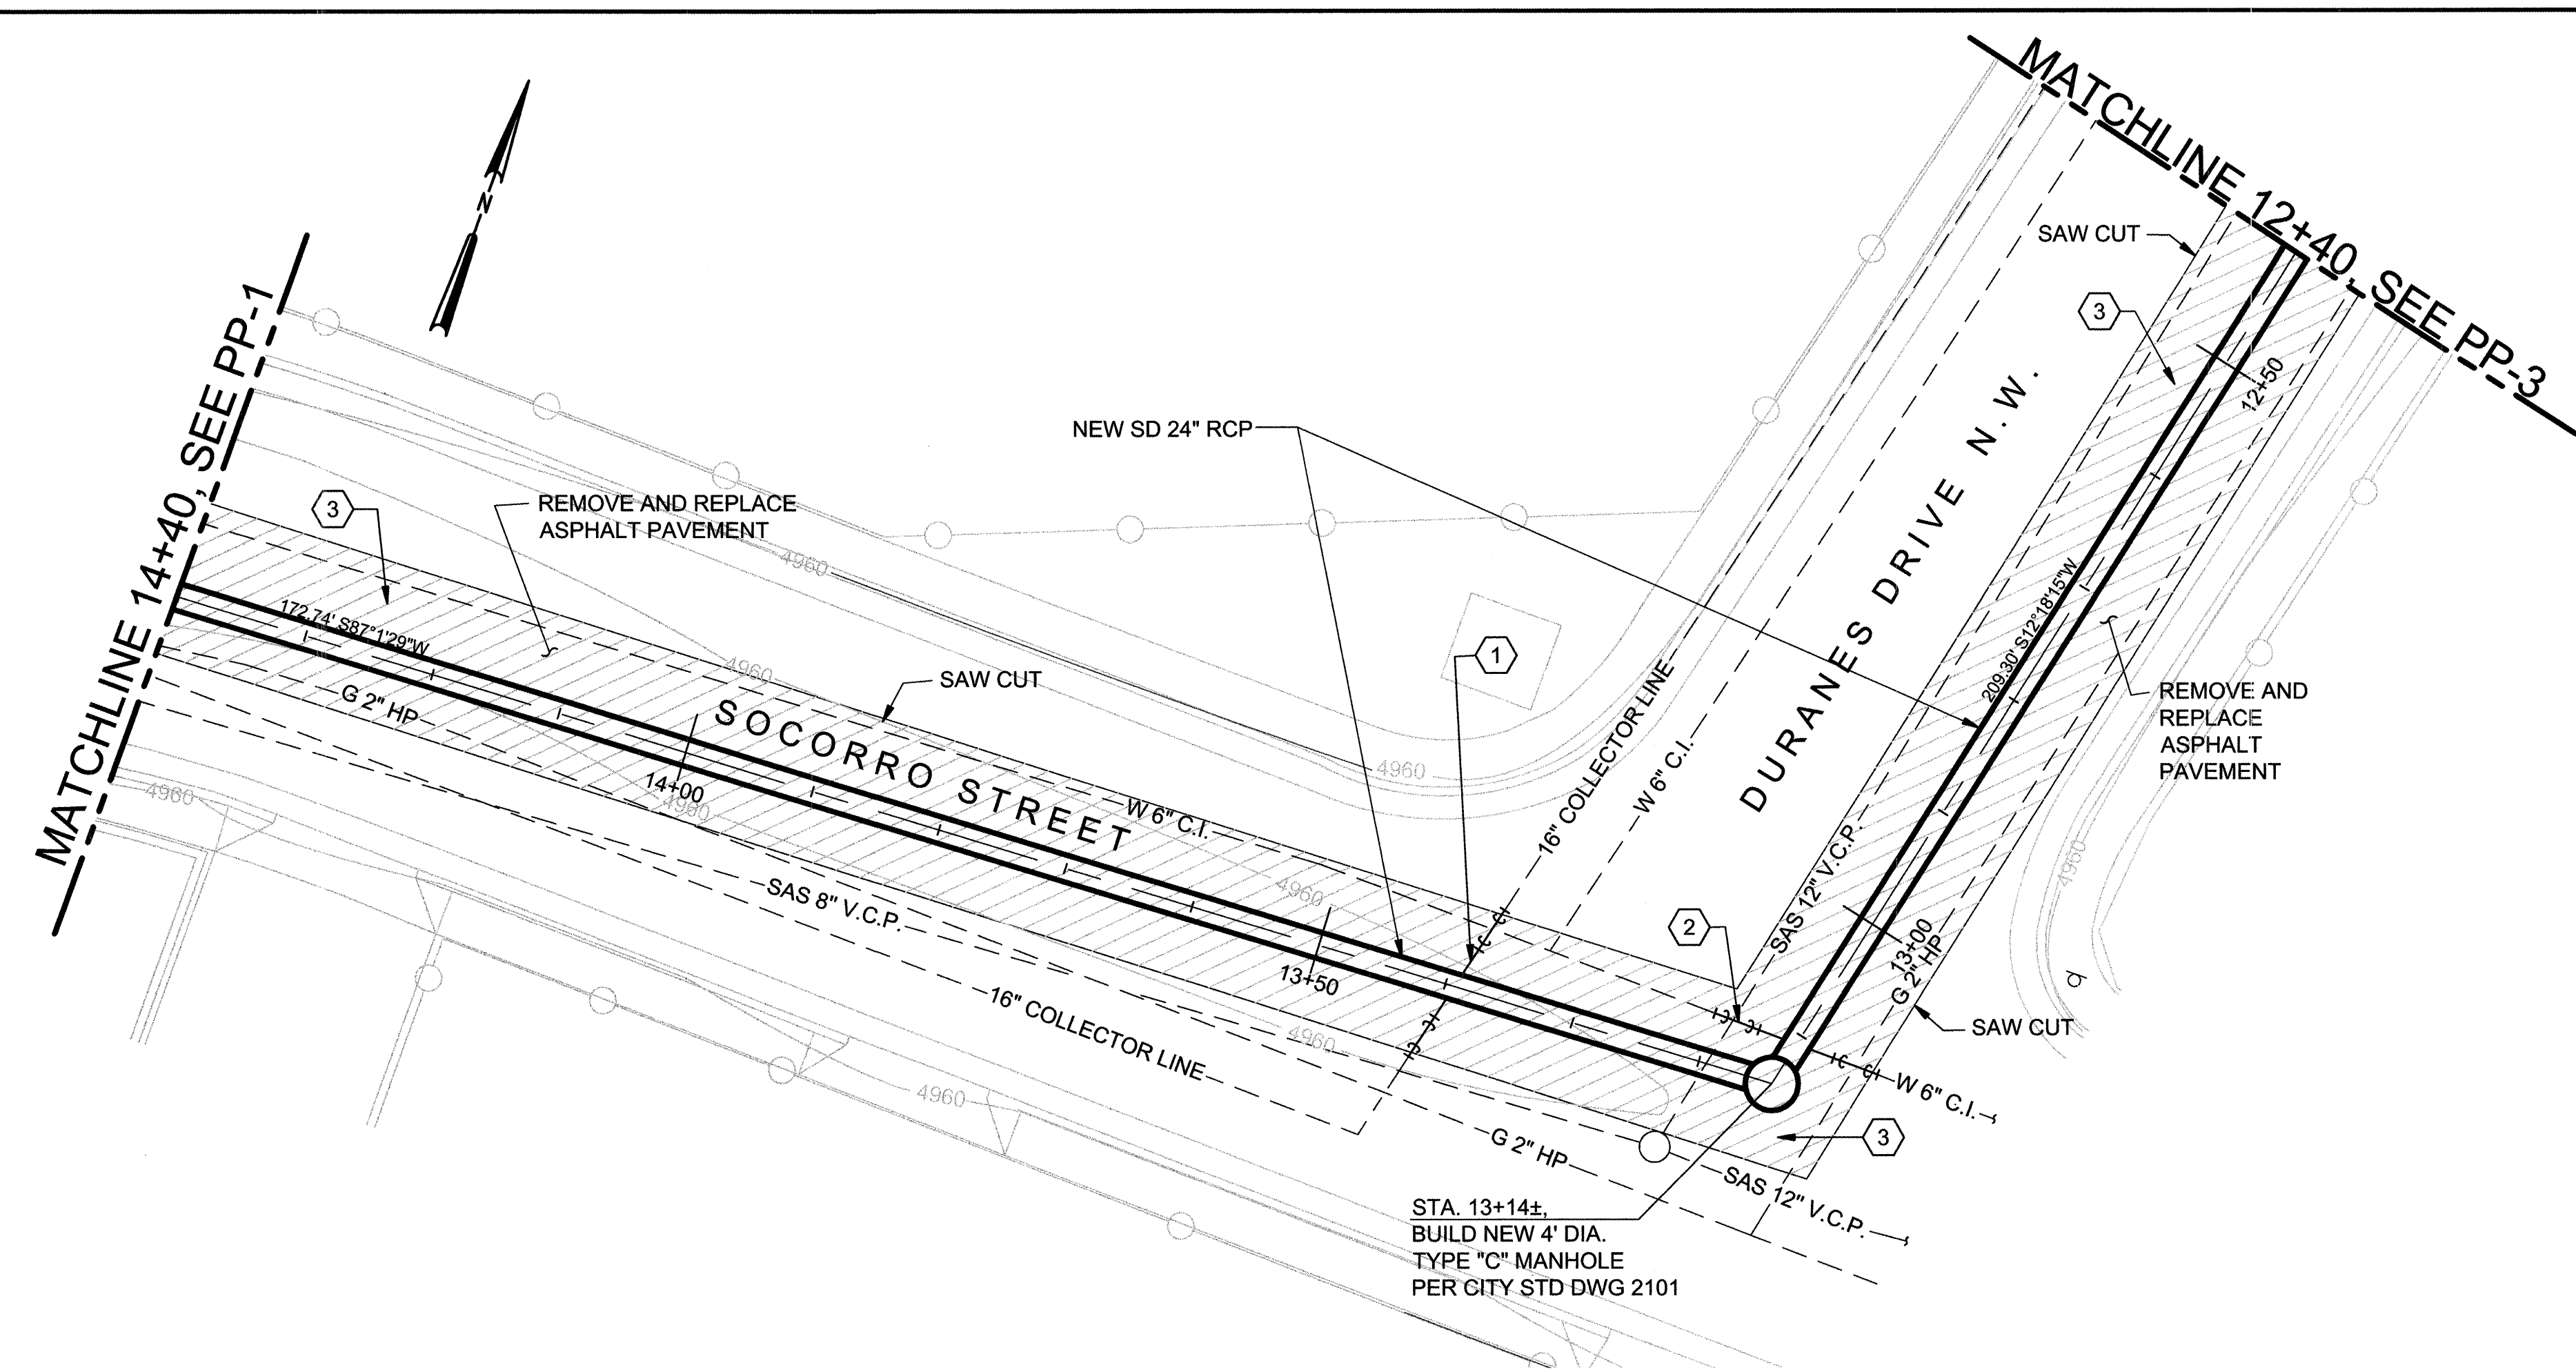

- KEYED NOTES
- 1 LOWER EXISTING 16" COLLECTOR LINE, SEE 1
 - 2 LOWER EXISTING 6" WATER LINE, SEE 2
 - 3 REMOVE AND REPLACE ASPHALT PAVEMENT PER COA STD DWG 2465. PAVEMENT CUTS MUST BE ORTHOGONAL TO FLOW OF TRAFFIC.

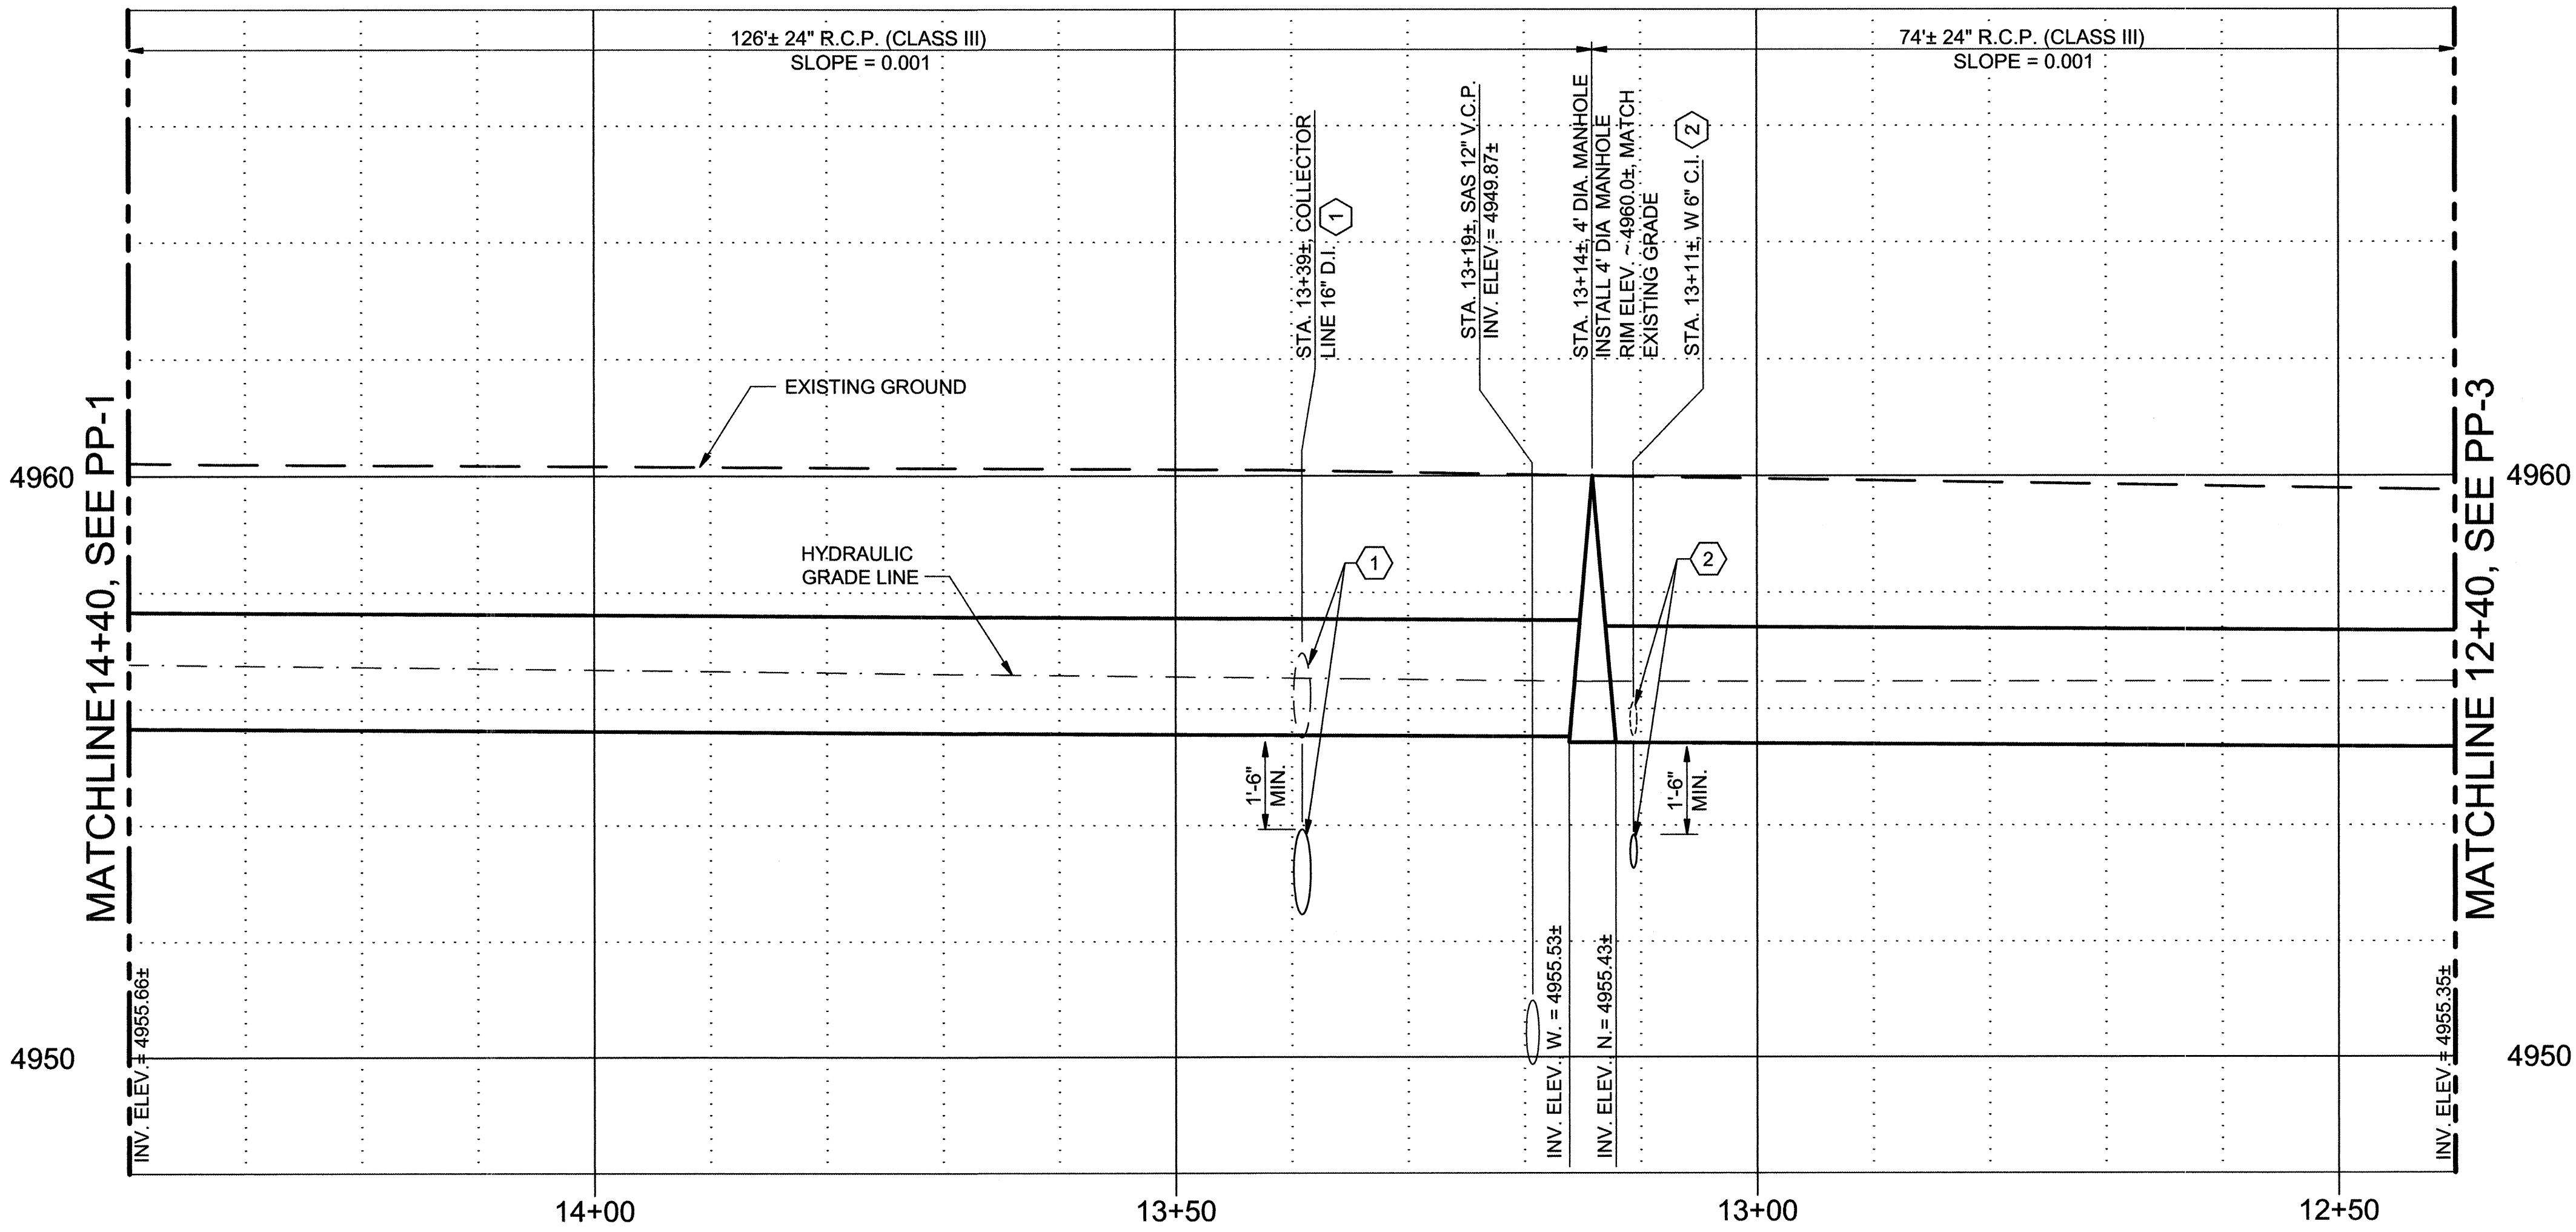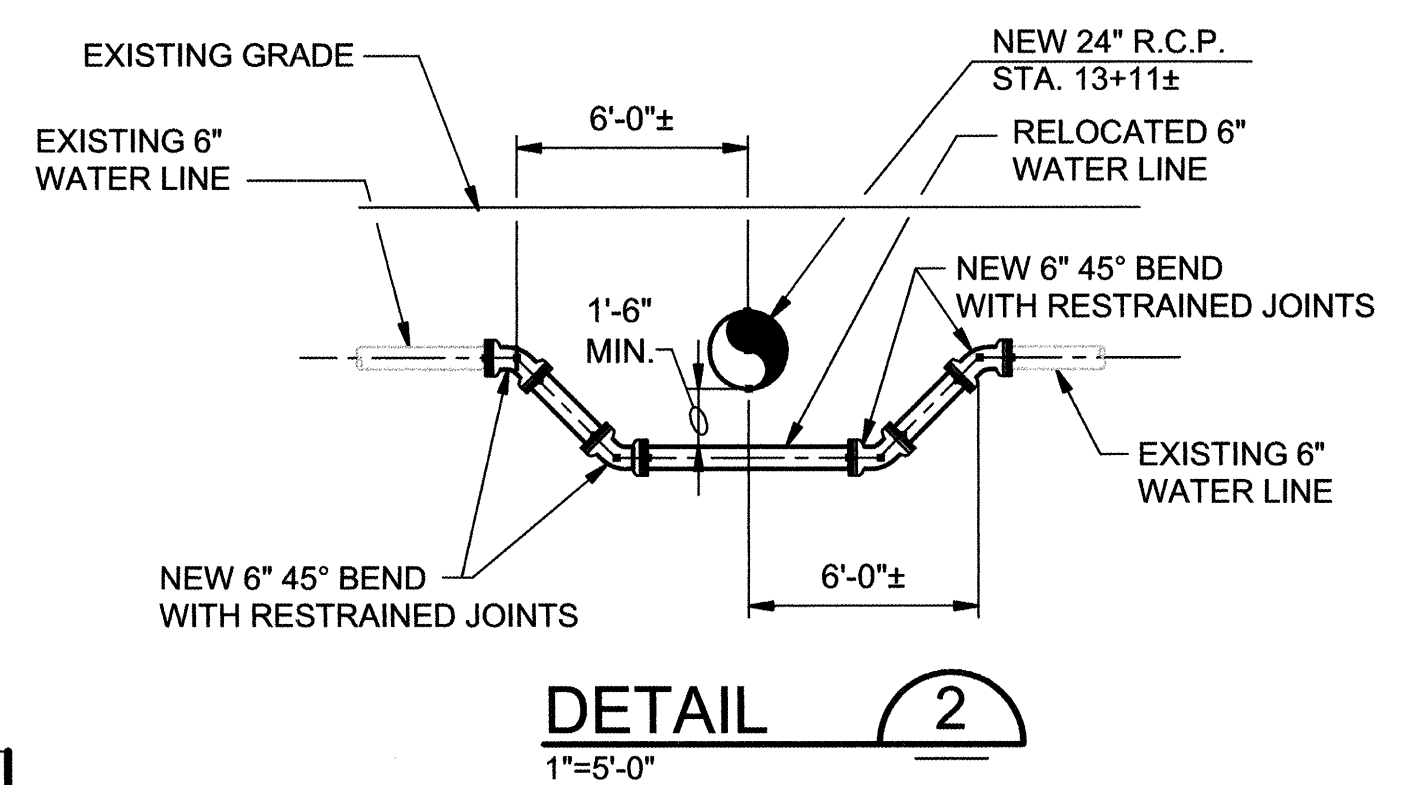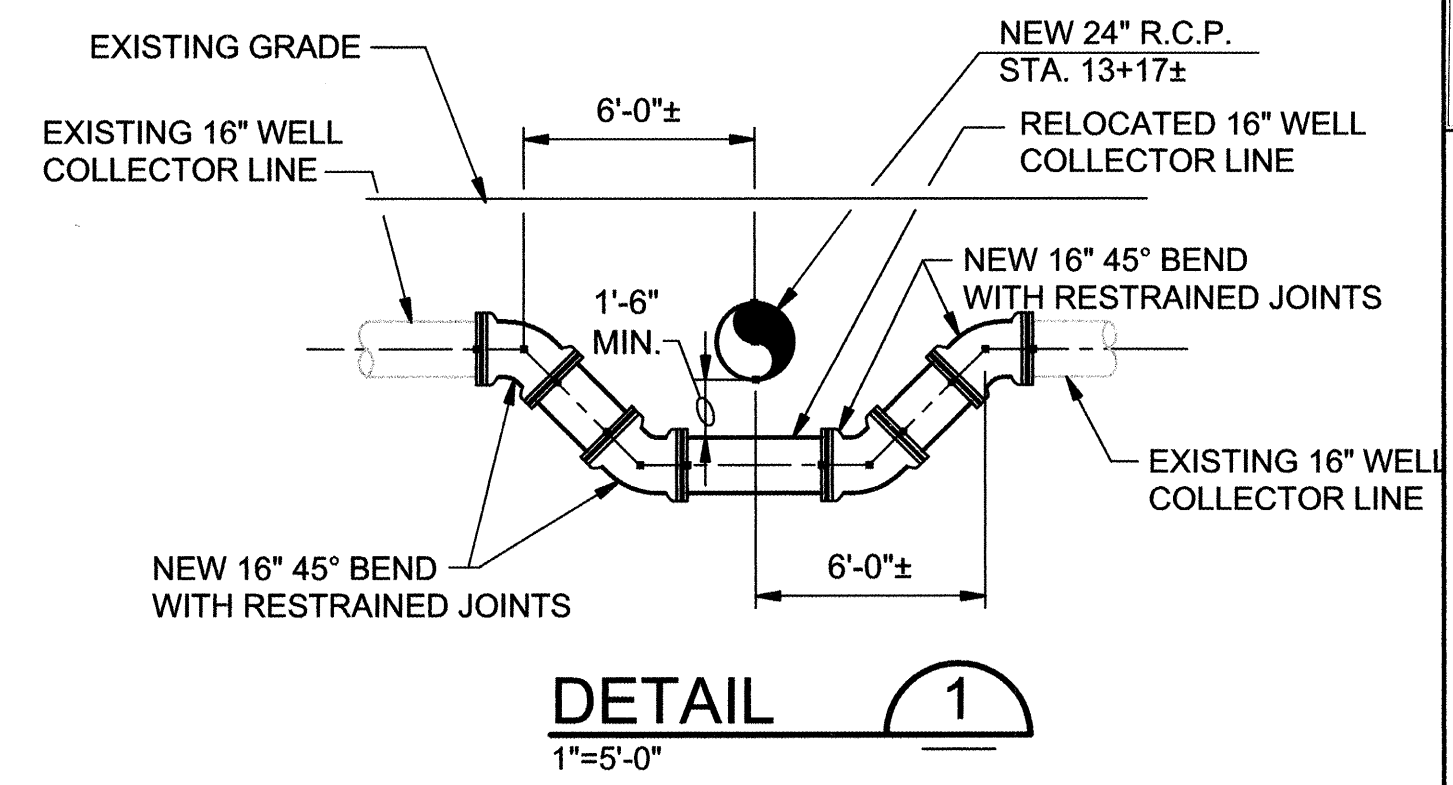

RECORD DRAWINGS

Revisions Drawn by EJA Date 07/2007

THESE RECORD DRAWINGS HAVE BEEN PREPARED, IN PART, ON THE BASIS OF INFORMATION COMPILED BY OTHERS. THEY ARE NOT INTENDED TO REPRESENT IN DETAIL THE EXACT LOCATION, TYPE OF COMPONENT NOR MANNER OF CONSTRUCTION. THE ENGINEER WILL NOT BE RESPONSIBLE FOR ANY ERRORS OR OMISSIONS WHICH HAVE BEEN INCORPORATED INTO THE RECORD DRAWINGS.

SCALE: HORIZONTAL: 1"=10'
VERTICAL: 1"=2'

CH2MHILL

6001 Indian School Rd, N.E., SUITE 350
Albuquerque, New Mexico 87110
(505) 884-5600





Albuquerque Bernalillo County
Water Utility Authority

TITLE: DURANES WELLS 2, 3 AND 6 WASHLINE MODIFICATIONS
DURANES WELL #3 WASH LINE - STA. 12+40 TO STA. 14+40

Design Review Committee	City Engineer Approval	Mo./Day/Yr.	Mo./Day/Yr.

CITY PROJECT NO. 7279-03 Zone Map No. H-12 SHEET 11 OF 16
DRAWING NO. 2-PP-2

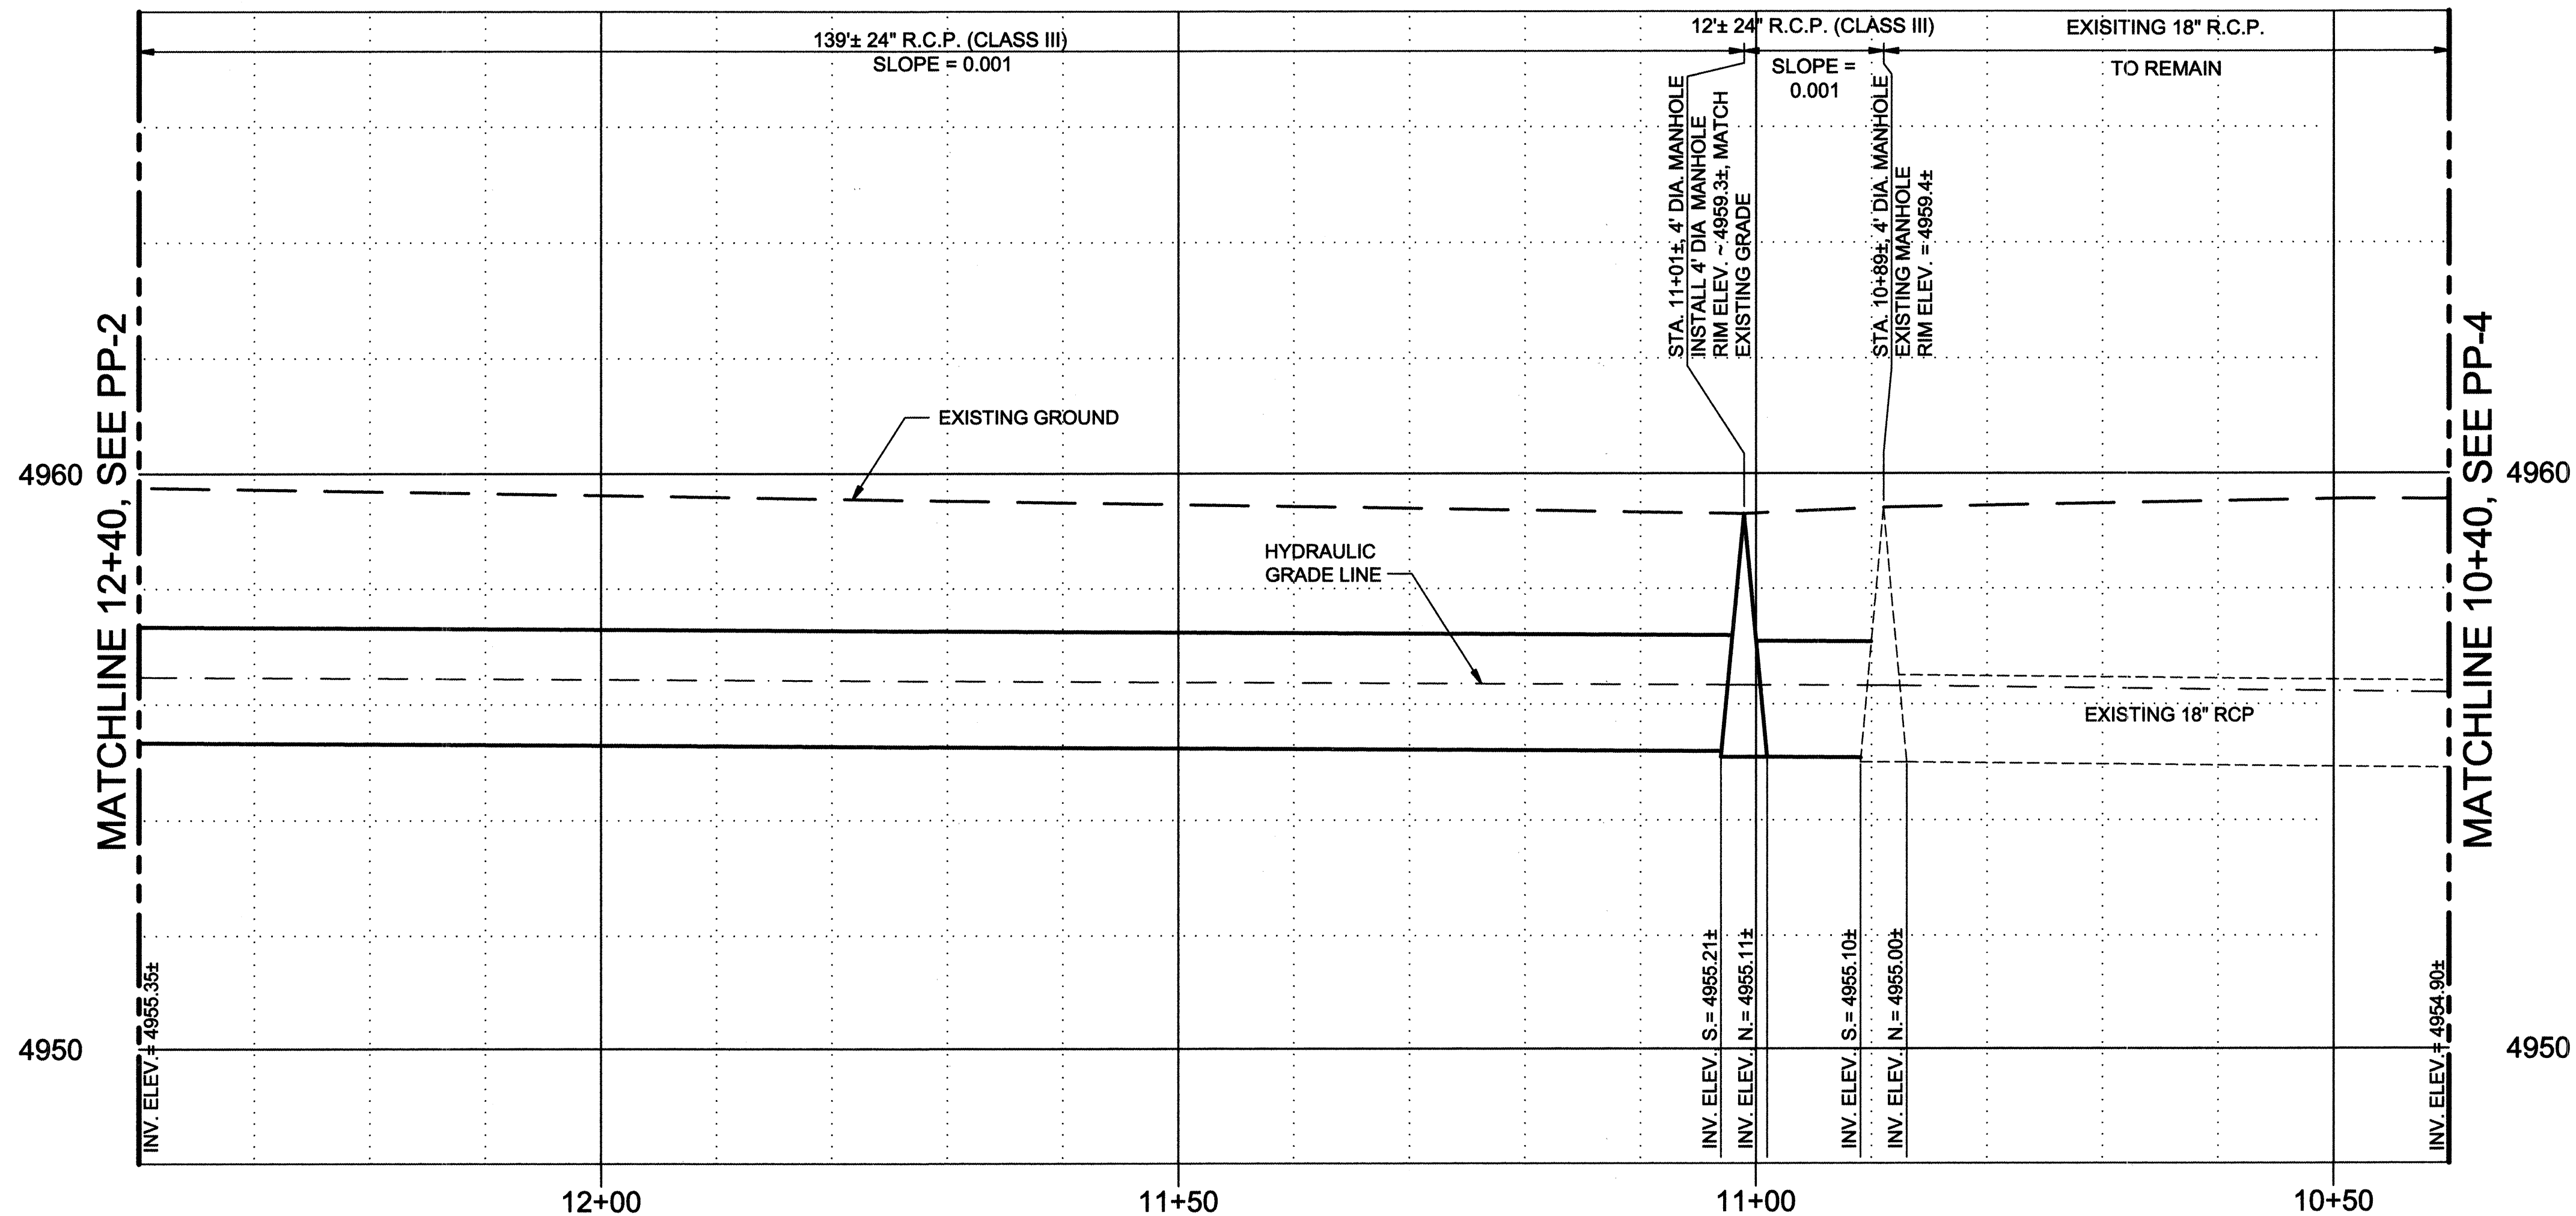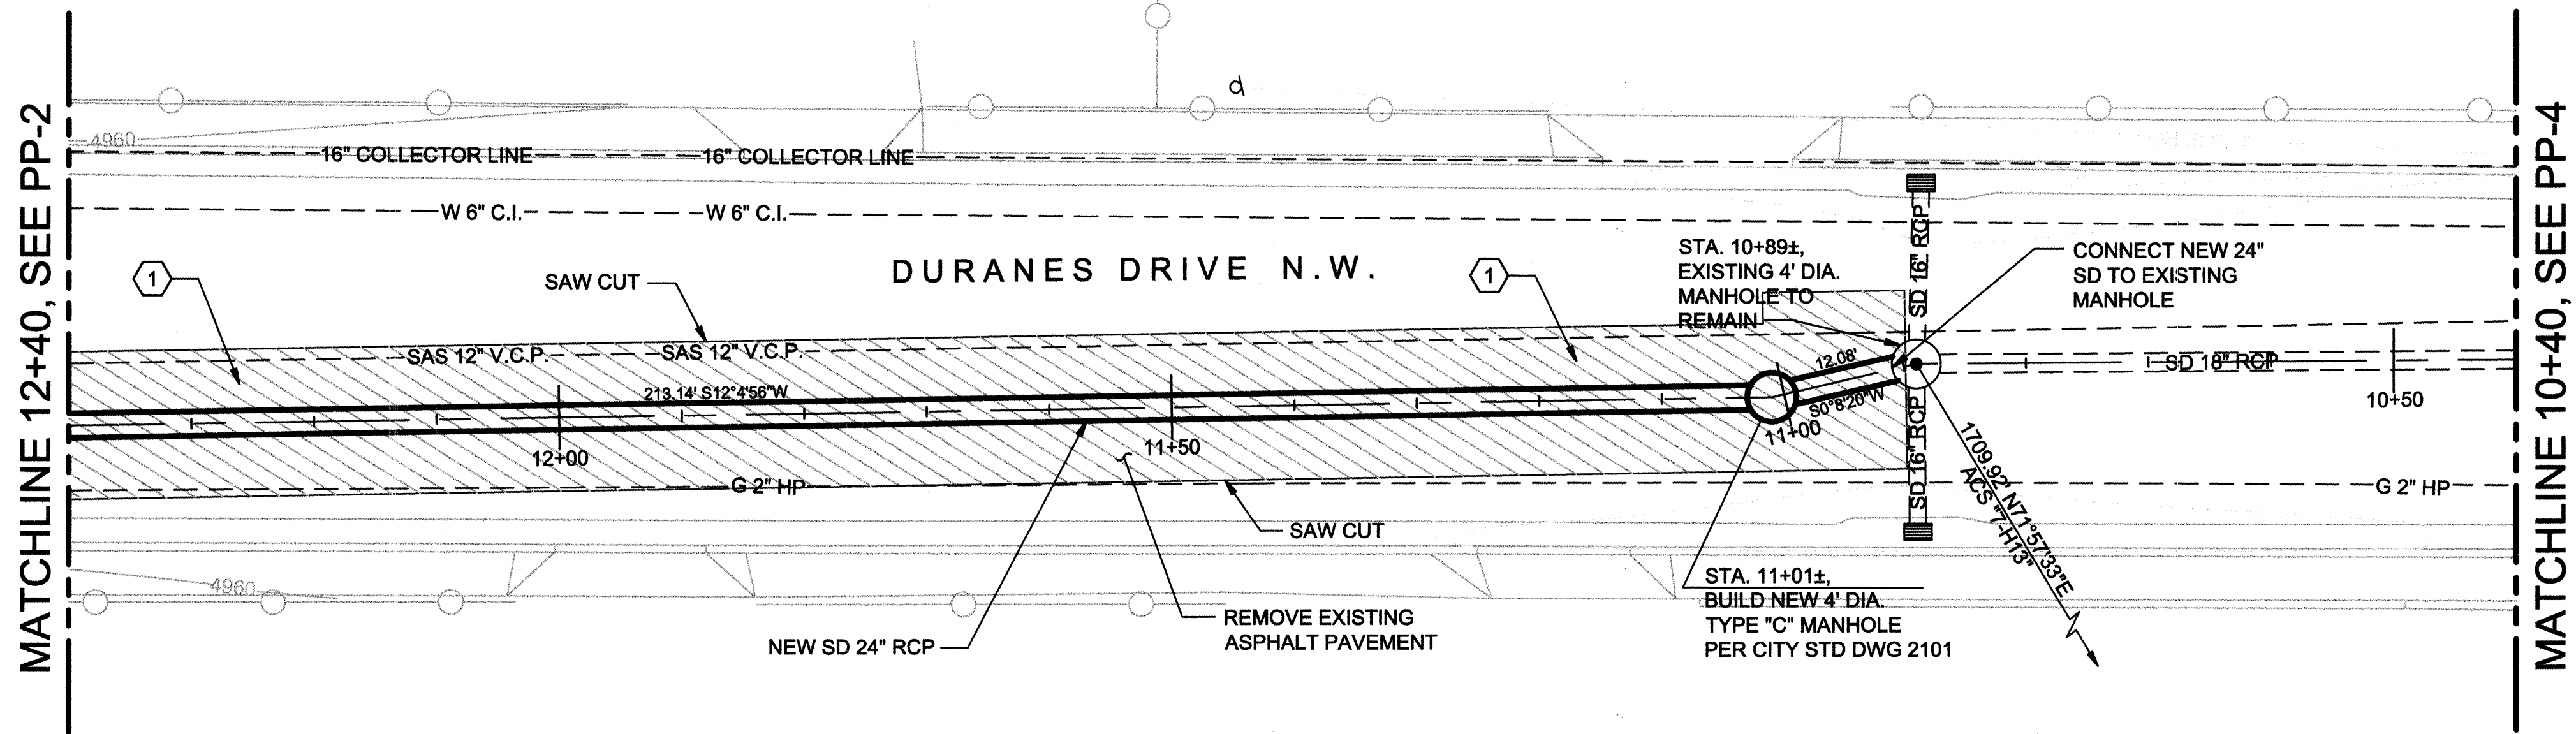

KEYED NOTES
 ① REMOVE AND REPLACE ASPHALT PAVEMENT PER COA STD DWG 2465. PAVEMENT CUTS MUST BE ORTHOGONAL TO FLOW OF TRAFFIC.

AS BUILT INFORMATION		BENCH MARKS		SURVEY INFORMATION		ENGINEER'S SEAL		REVISIONS		DESIGNED BY		DRAWN BY		CHECKED BY	
CONTRACTOR	WORK	DATE	STATION	NO.	BY	DATE	NO.	DATE	REMARKS	DATE	DATE	DATE	DATE	DATE	DATE
NEWMECO UNDERGROUND CONTRACTORS INC.	INDIAN SCHOOL RD. N.W. AND INDIAN SCHOOL RD. N.W.	04/20/07	STATION IS AN ACS BRASS TABLET, STAMPED "7-H13".												
INSPECTED BY	CH2MHILL	08/20/07	X=373,826.5787 Y=1,496,192.2271 EL.=4,961.72.												
VERIFICATION BY	CH2MHILL	08/20/07	BM#2 LOCATED AT THE INTERSECTION OF CENTRAL AVENUE AND RIO GRANDE BLVD. N.W. STATION IS AN ACS ALUMINUM CAP STAMPED "9-H13, 1985".												
DATE	CH2MHILL	08/20/07	X=374,221.8747 Y=1,495,472.4277 EL.=4,960.53.												
RECORDED BY															
NO.															

THIS SHEET SUPERSEDED BY
 SIMILAR SHEET MARKED
 "RECORD DRAWING"

SCALE: HORIZONTAL: 1"=10'
 VERTICAL: 1"=2'

CH2MHILL



6001 Indian School Rd, N.E., SUITE 350
 Albuquerque, New Mexico 87110
 (505) 884-5600

Albuquerque Bernalillo County
Water Utility Authority

TITLE: DURANES WELLS 2, 3 AND 6 WASHLINE MODIFICATIONS
DURANES WELL #3 WASH LINE - STA. 10+40 TO STA. 12+40

Design Review Committee	City Engineer Approval	Mo./Day/Yr.	Mo./Day/Yr.
SEP 26 2006	SEP 26 2006		
DESIGN REVIEW COMMITTEE	CITY ENGINEER		

CITY PROJECT NO. 7279-03 Zone Map No. H-12 SHEET 12 OF 16
 DRAWING NO. 2-PP-3

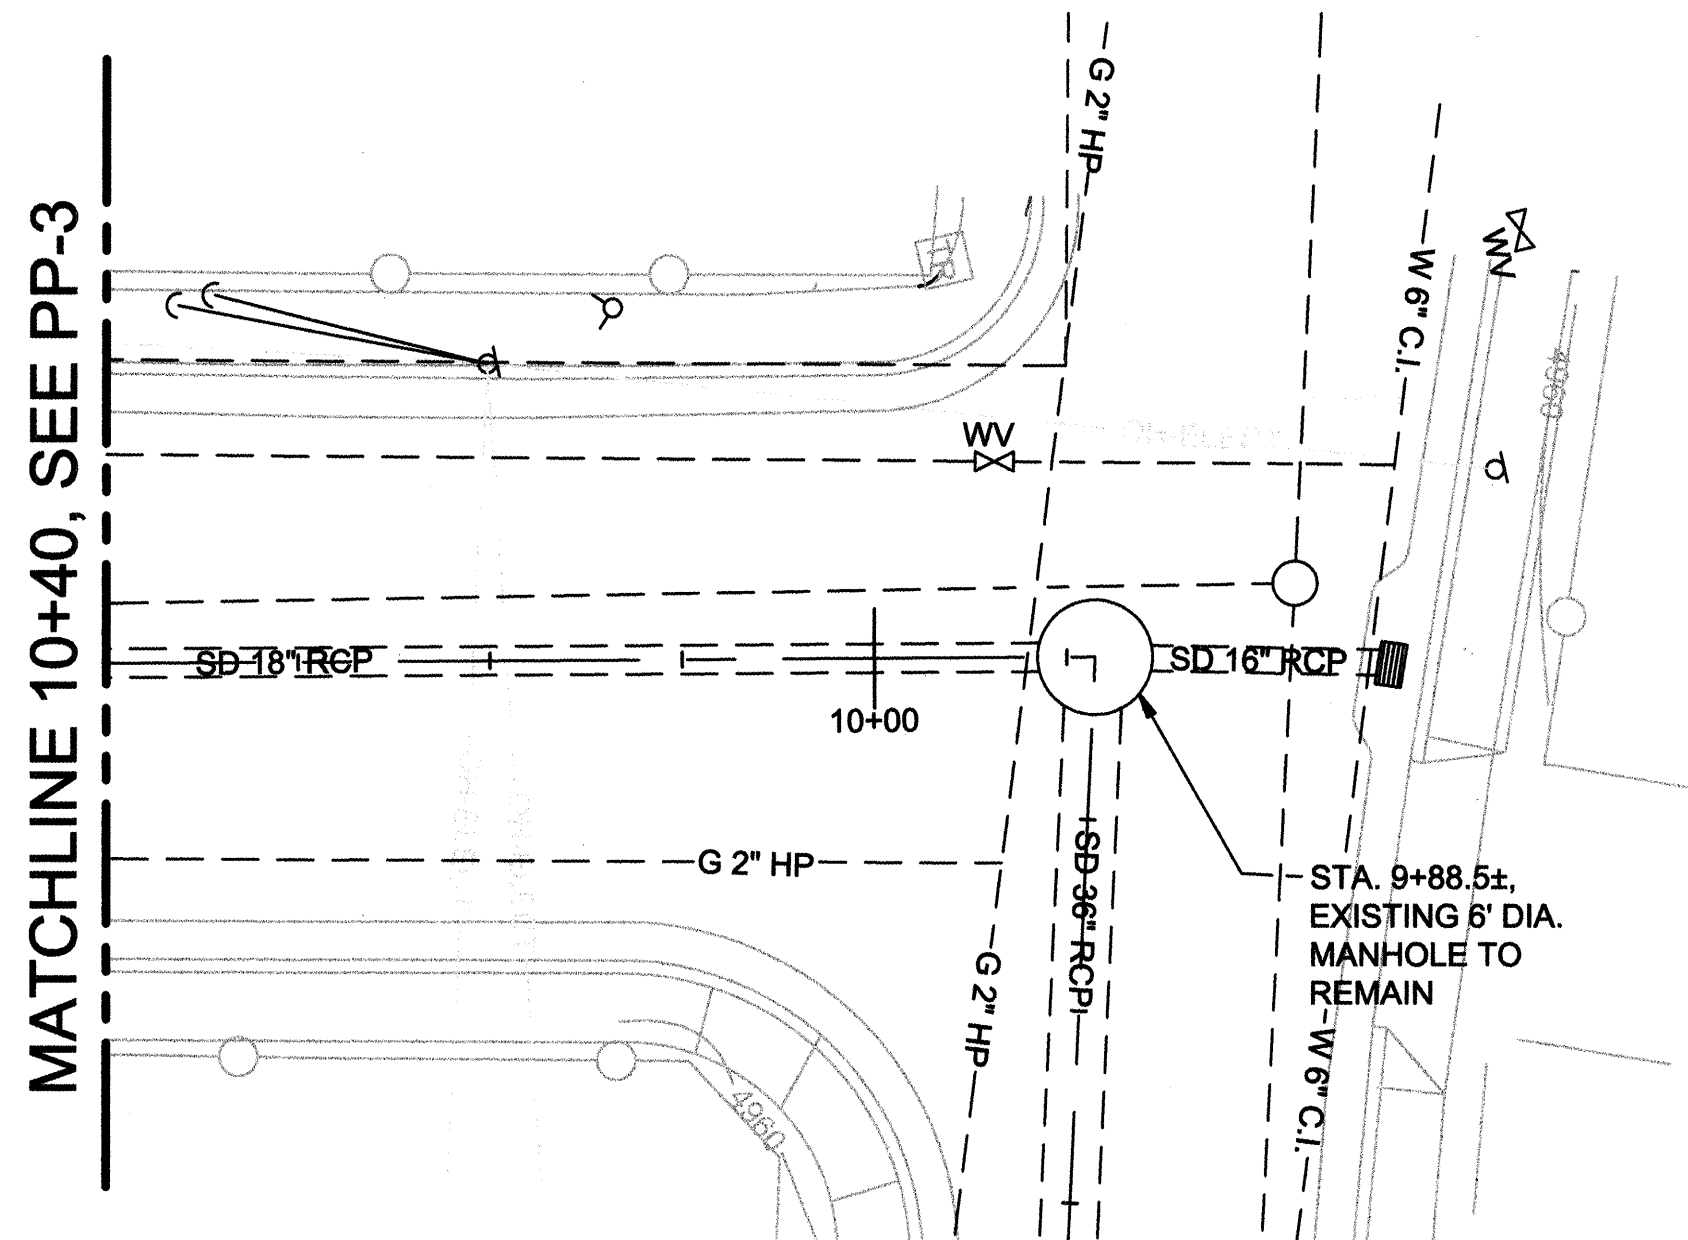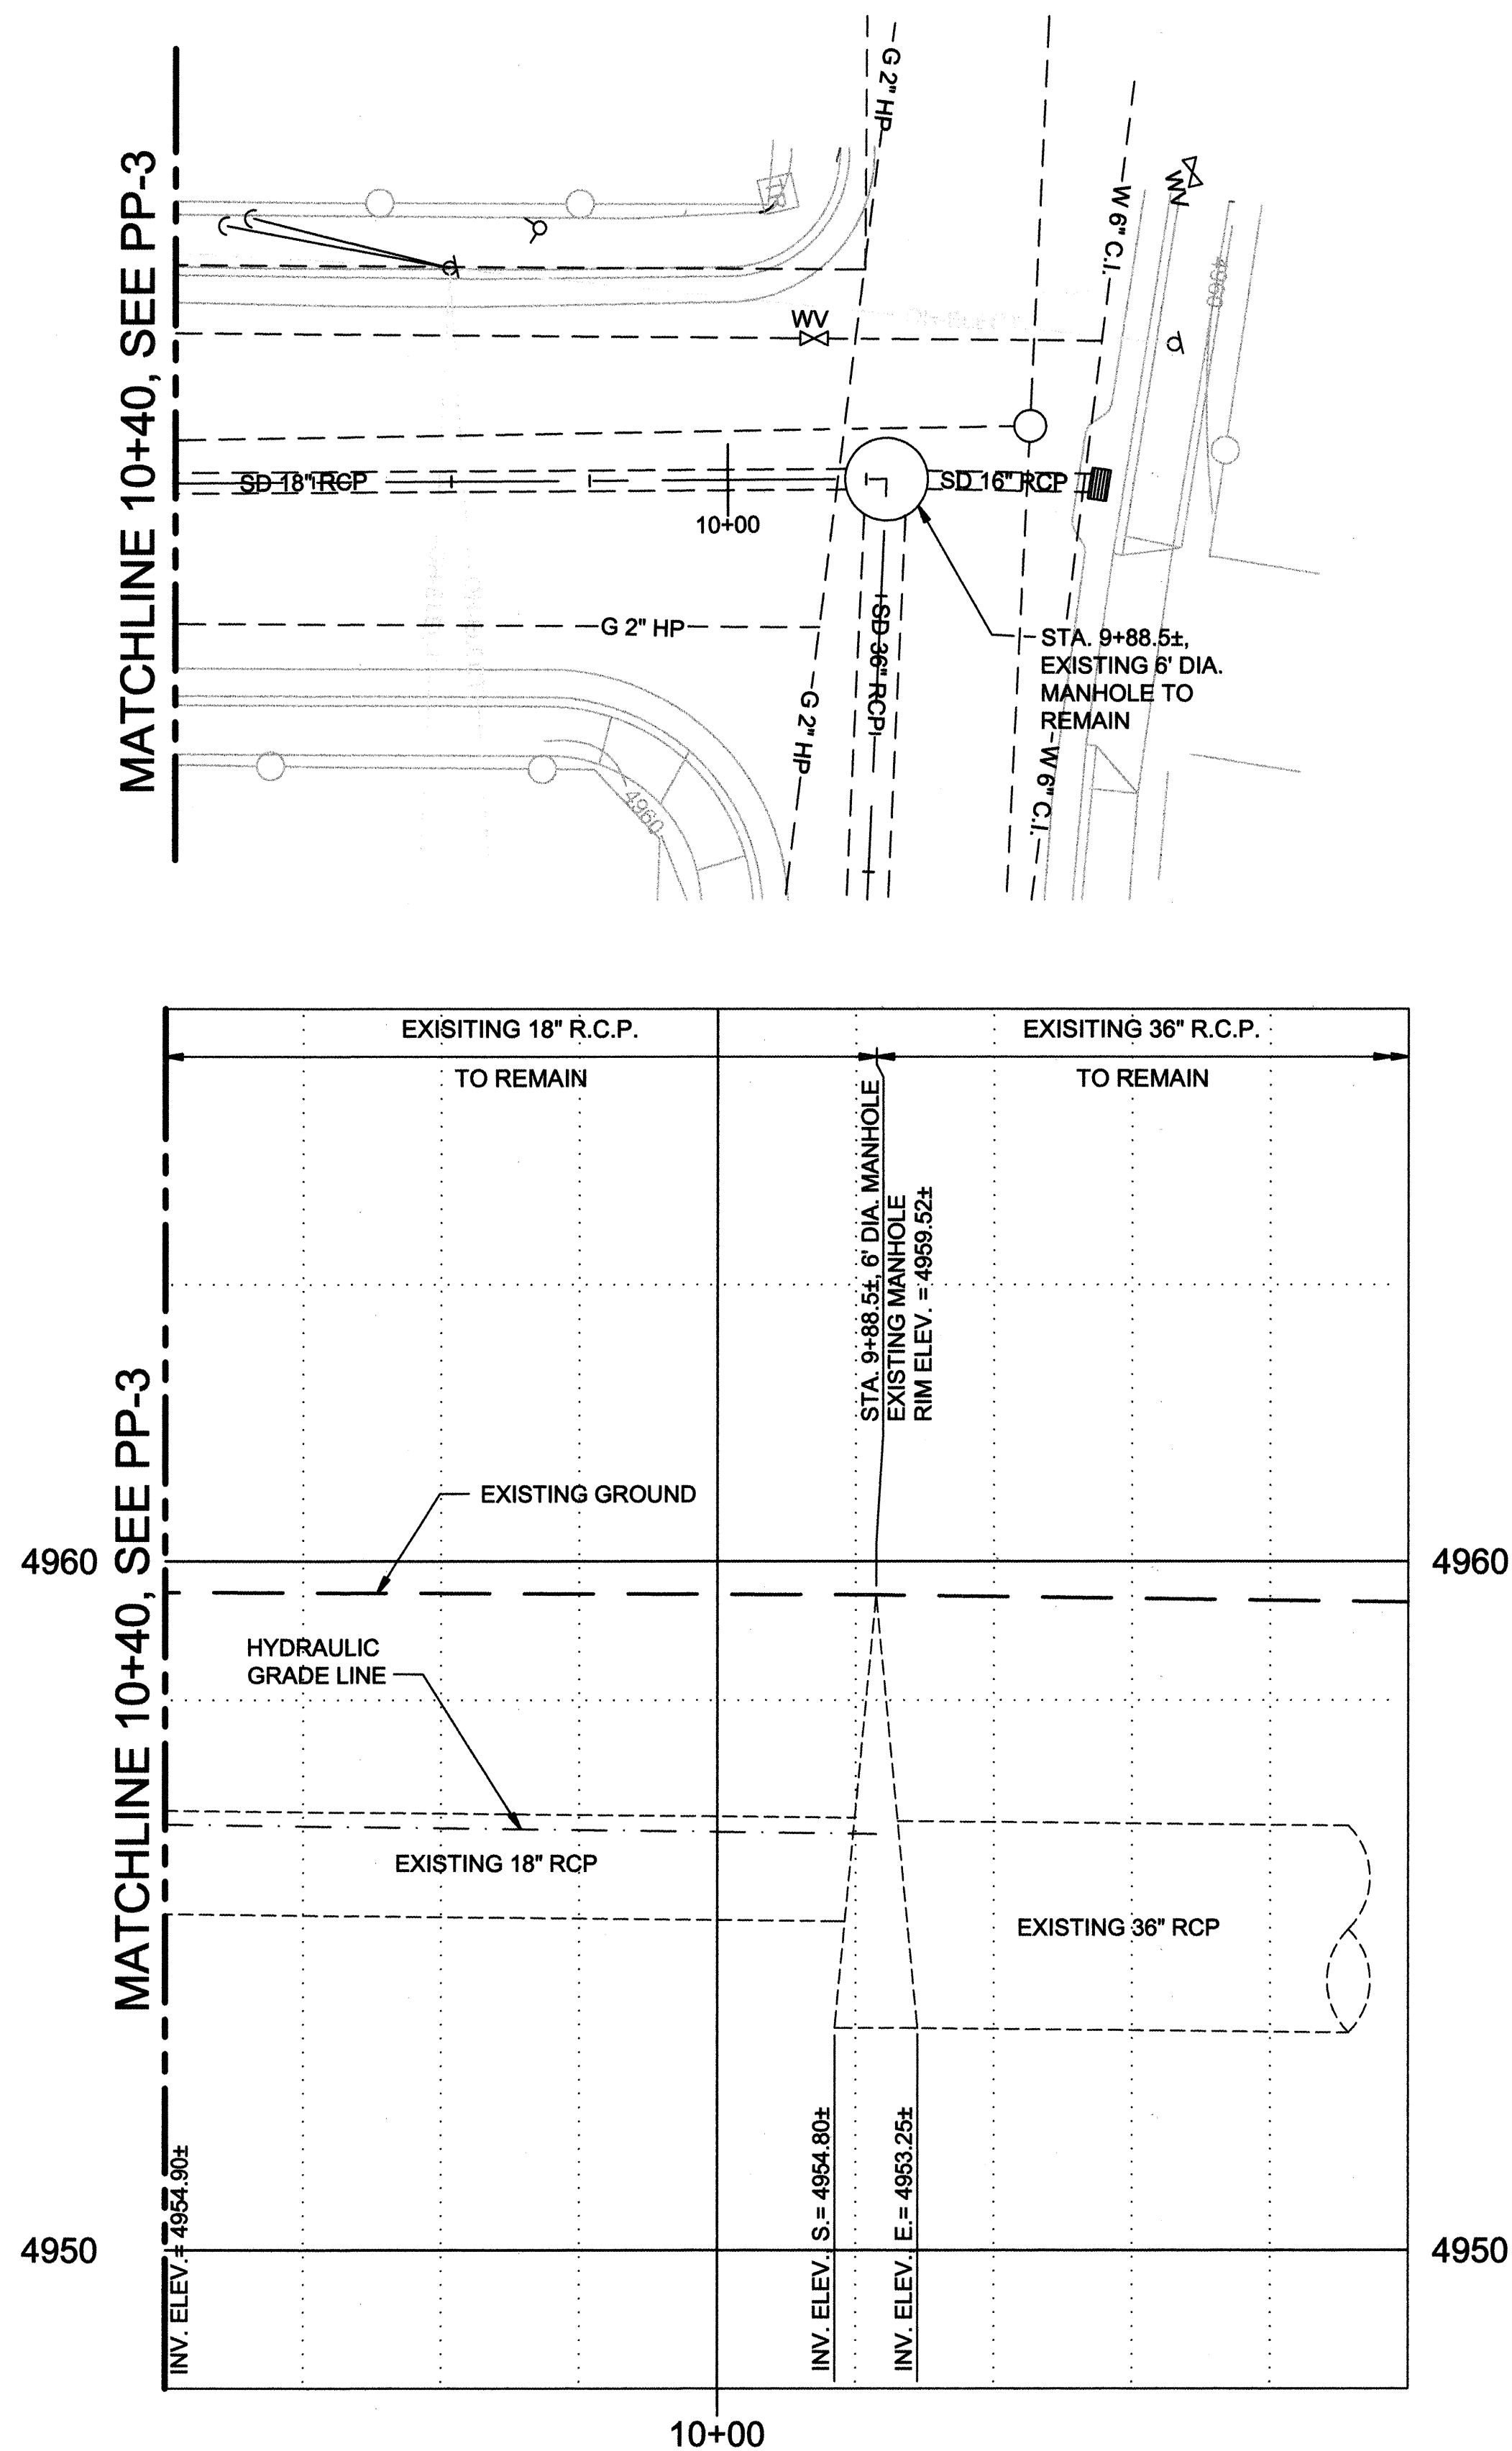

VERIFY SCALES
BAR IS ONE INCH ON
ORIGINAL DRAWING
0 1"
IF NOT ONE INCH ON
THIS SHEET, ADJUST
SCALES ACCORDINGLY.

RECORD DRAWINGS
Revisions Drawn by EJA Date 07/2005
THESE RECORD DRAWINGS HAVE BEEN PREPARED, IN PART, ON THE BASIS OF INFORMATION COMPILED BY OTHERS. THEY ARE NOT INTENDED TO REPRESENT IN DETAIL THE EXACT LOCATION, TYPE OF COMPONENT NOR MANNER OF CONSTRUCTION. THE ENGINEER WILL NOT BE RESPONSIBLE FOR ANY ERRORS OR OMISSIONS WHICH HAVE BEEN INCORPORATED INTO THE RECORD DRAWINGS.

SCALE: HORIZONTAL: 1"=10'
VERTICAL 1"=2'


CH2MHILL
6001 Indian School Rd, N.E., SUITE 350
Albuquerque, New Mexico 87110
(505) 884-5600


Albuquerque Bernalillo County
Water Utility Authority

TITLE: DURANES WELLS 2, 3 AND 6 WASHLINE MODIFICATIONS
DURANES WELL #3 WASH LINE - STA. 9+50 TO STA. 10+40


Design Review Committee	City Engineer Approval	Mo./Day/Yr.	Mo./Day/Yr.
APPROVE SEP 26 2006 DESIGN REVIEW COMMITTEE	APPROVE SEP 26 2006 CITY ENGINEER		
Last Design Update			

CITY PROJECT NO. 7279-03	Zone Map No. H-12	SHEET 13 OF 16 DRAWING NO. 2-PP-4
--------------------------	-------------------	--------------------------------------

 ENGINEER'S SEAL		SURVEY INFORMATION		BENCH MARKS		AS BUILT INFORMATION		
		FIELD NOTES		BM#1 LOCATED AT THE INTERSECTION OF RIO GRANDE BLVD. N.W. AND INDIAN SCHOOL RD. N.W. STATION IS AN ACS BRASS TABLET, STAMPED "7-H13". X=373.826, 5787 Y=1,496, 192, 2271 EL.=4,961.72.		CONTRACTOR: FERRA LAND SURVEYS, LLC, DATE: 04/2007		
		NO.	BY	DATE			INSPECTORS STAMPED BY: CH2MHILL, DATE: 08/2007	
							FIELD VERIFICATION BY: CH2MHILL, DATE: 08/2007	
							APPROVED BY: CH2MHILL, DATE: 08/2007	
							CORRECTED BY: CH2MHILL, DATE: 08/2007	
					BM#2 LOCATED AT THE INTERSECTION OF CENTRAL AVENUE AND RIO GRANDE BLVD. N.W. STATION IS AN ACS ALUMINUM CAP STAMPED "8-H13, 1985". X=374, 221, 8747 Y=1,495, 472, 4277 EL.=4,960.53.	MICRO FILM INFORMATION		
						RECORDED BY		
						DATE		
						NO.		
						HORIZ: NAD 27, VERT: SLD 29		
DESIGNED BY		LH	DATE	05/11/2005				
DRAWN BY		EJA	DATE	06/03/2005				
CHECKED BY		MAB	DATE	04/29/2006				

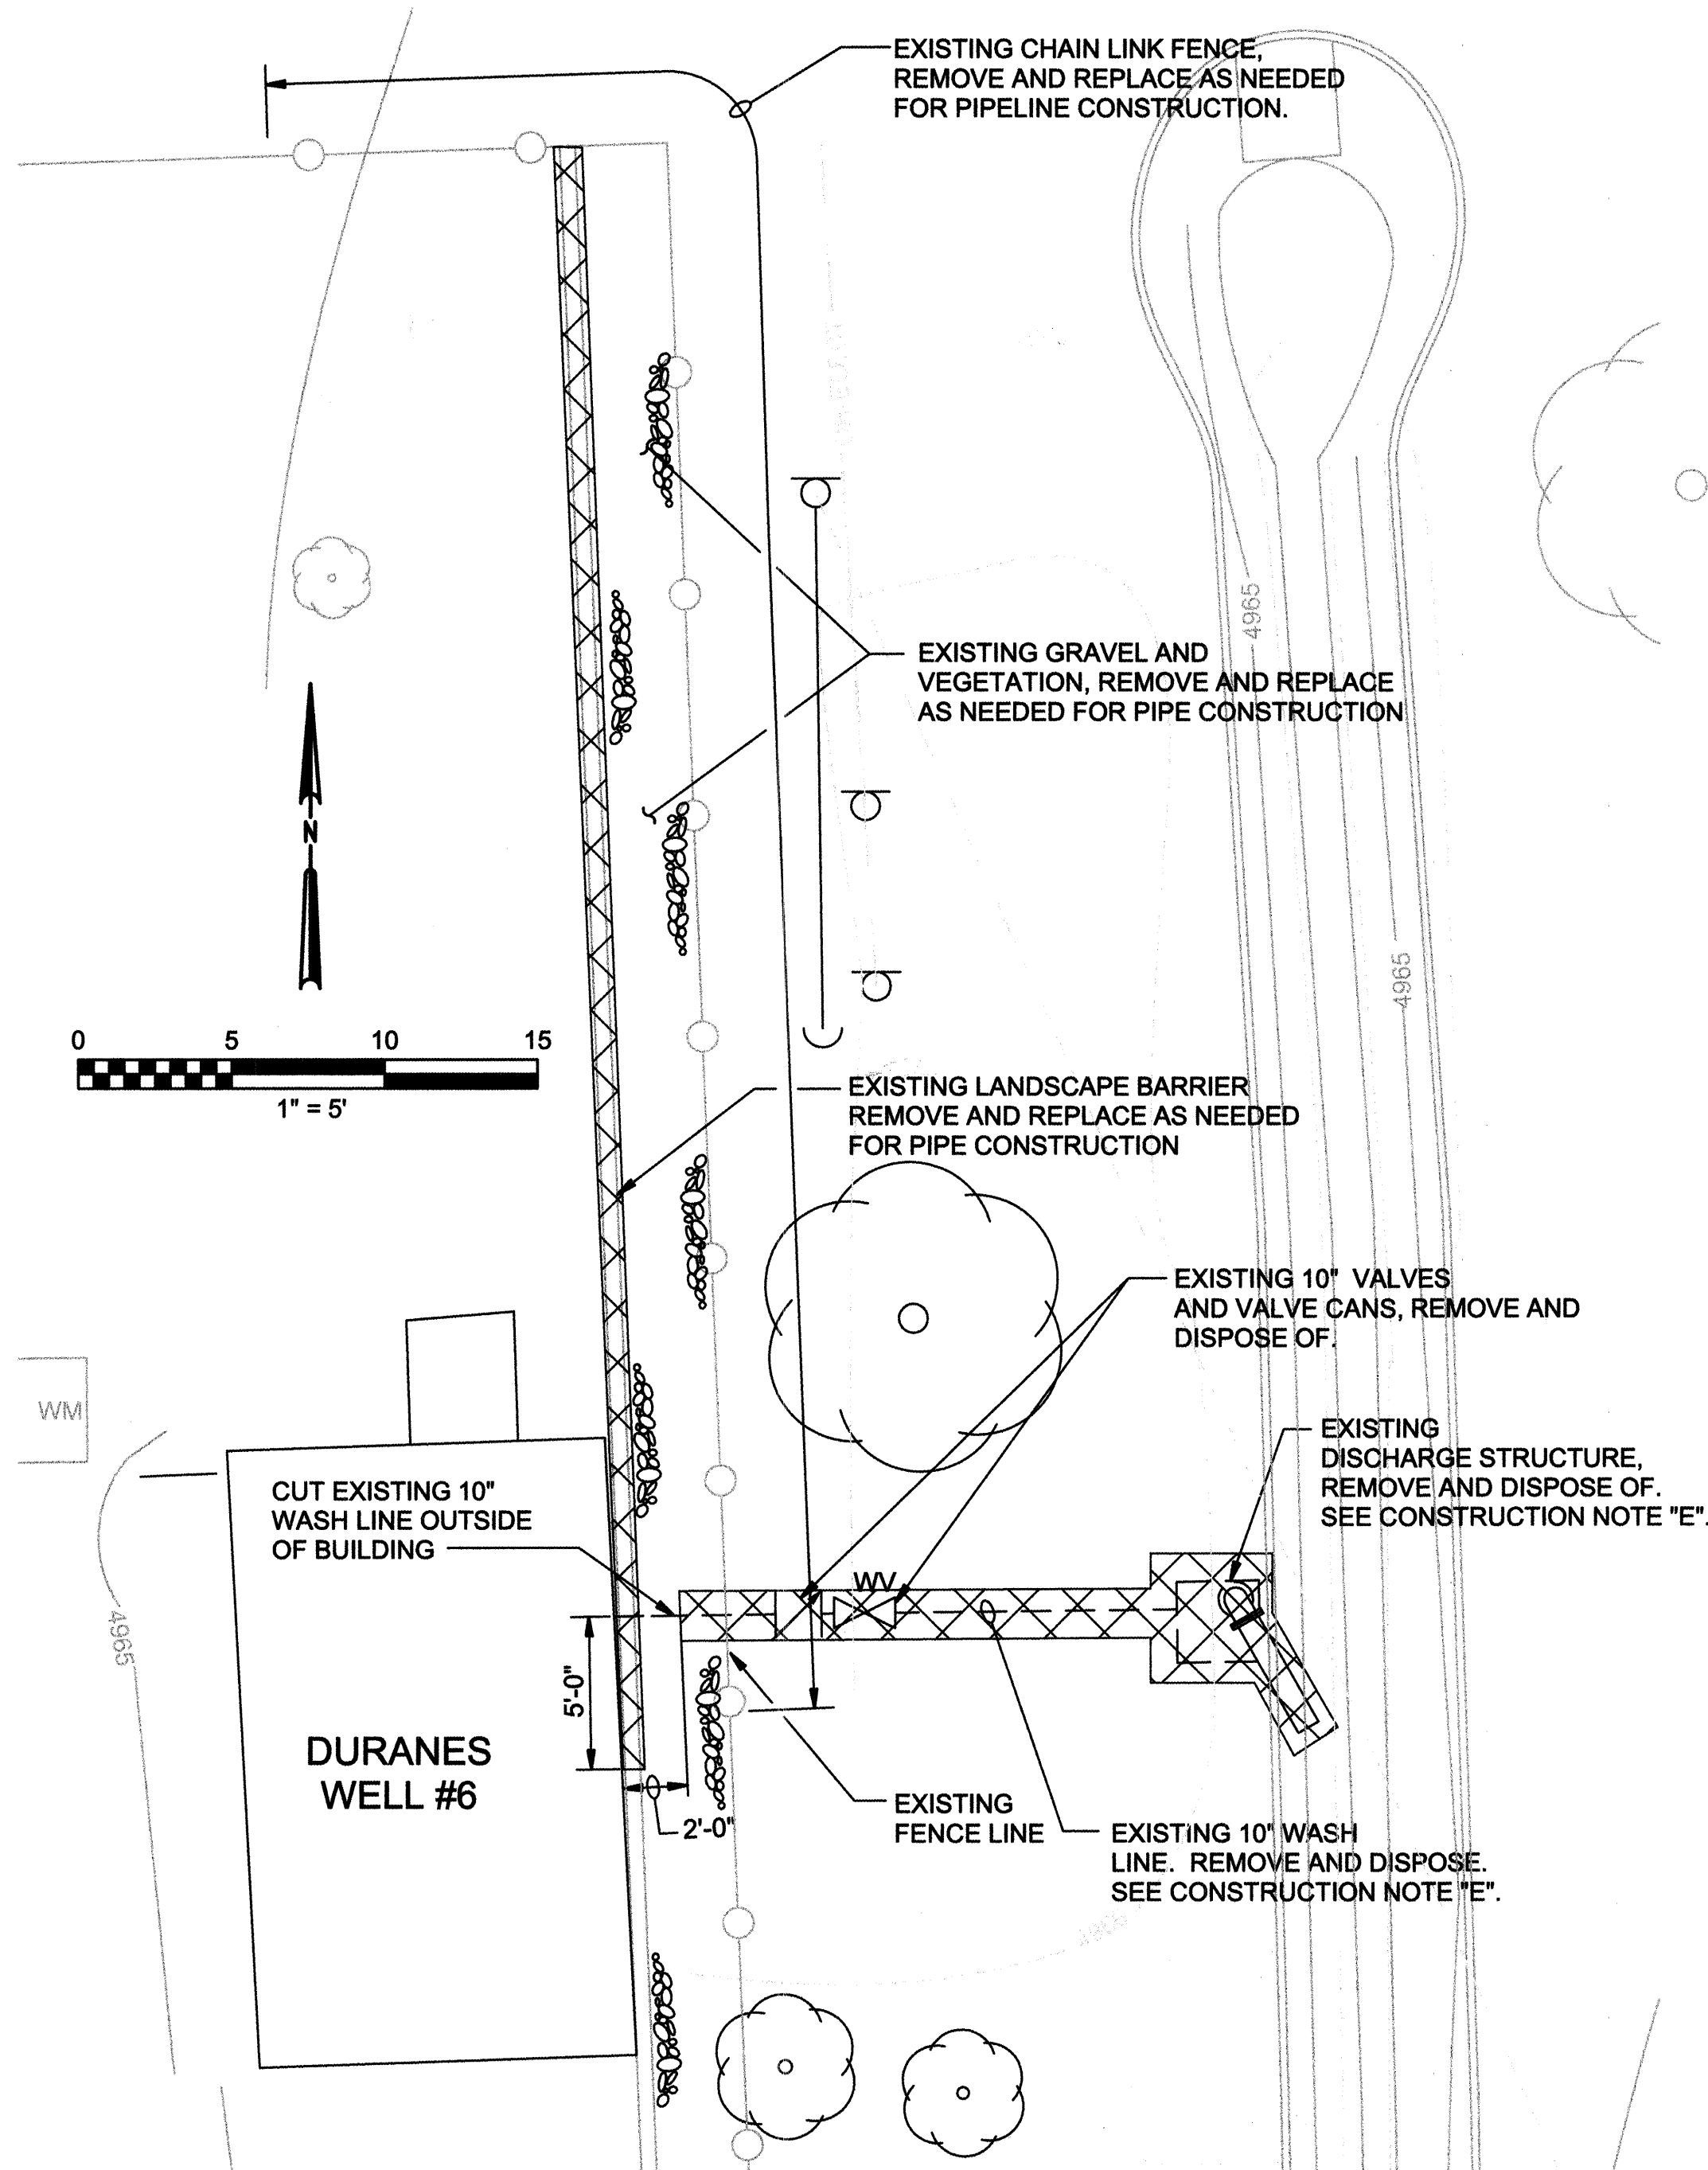

DURANES WELL #6 - DEMOLITION PLAN
1" = 5'-0"

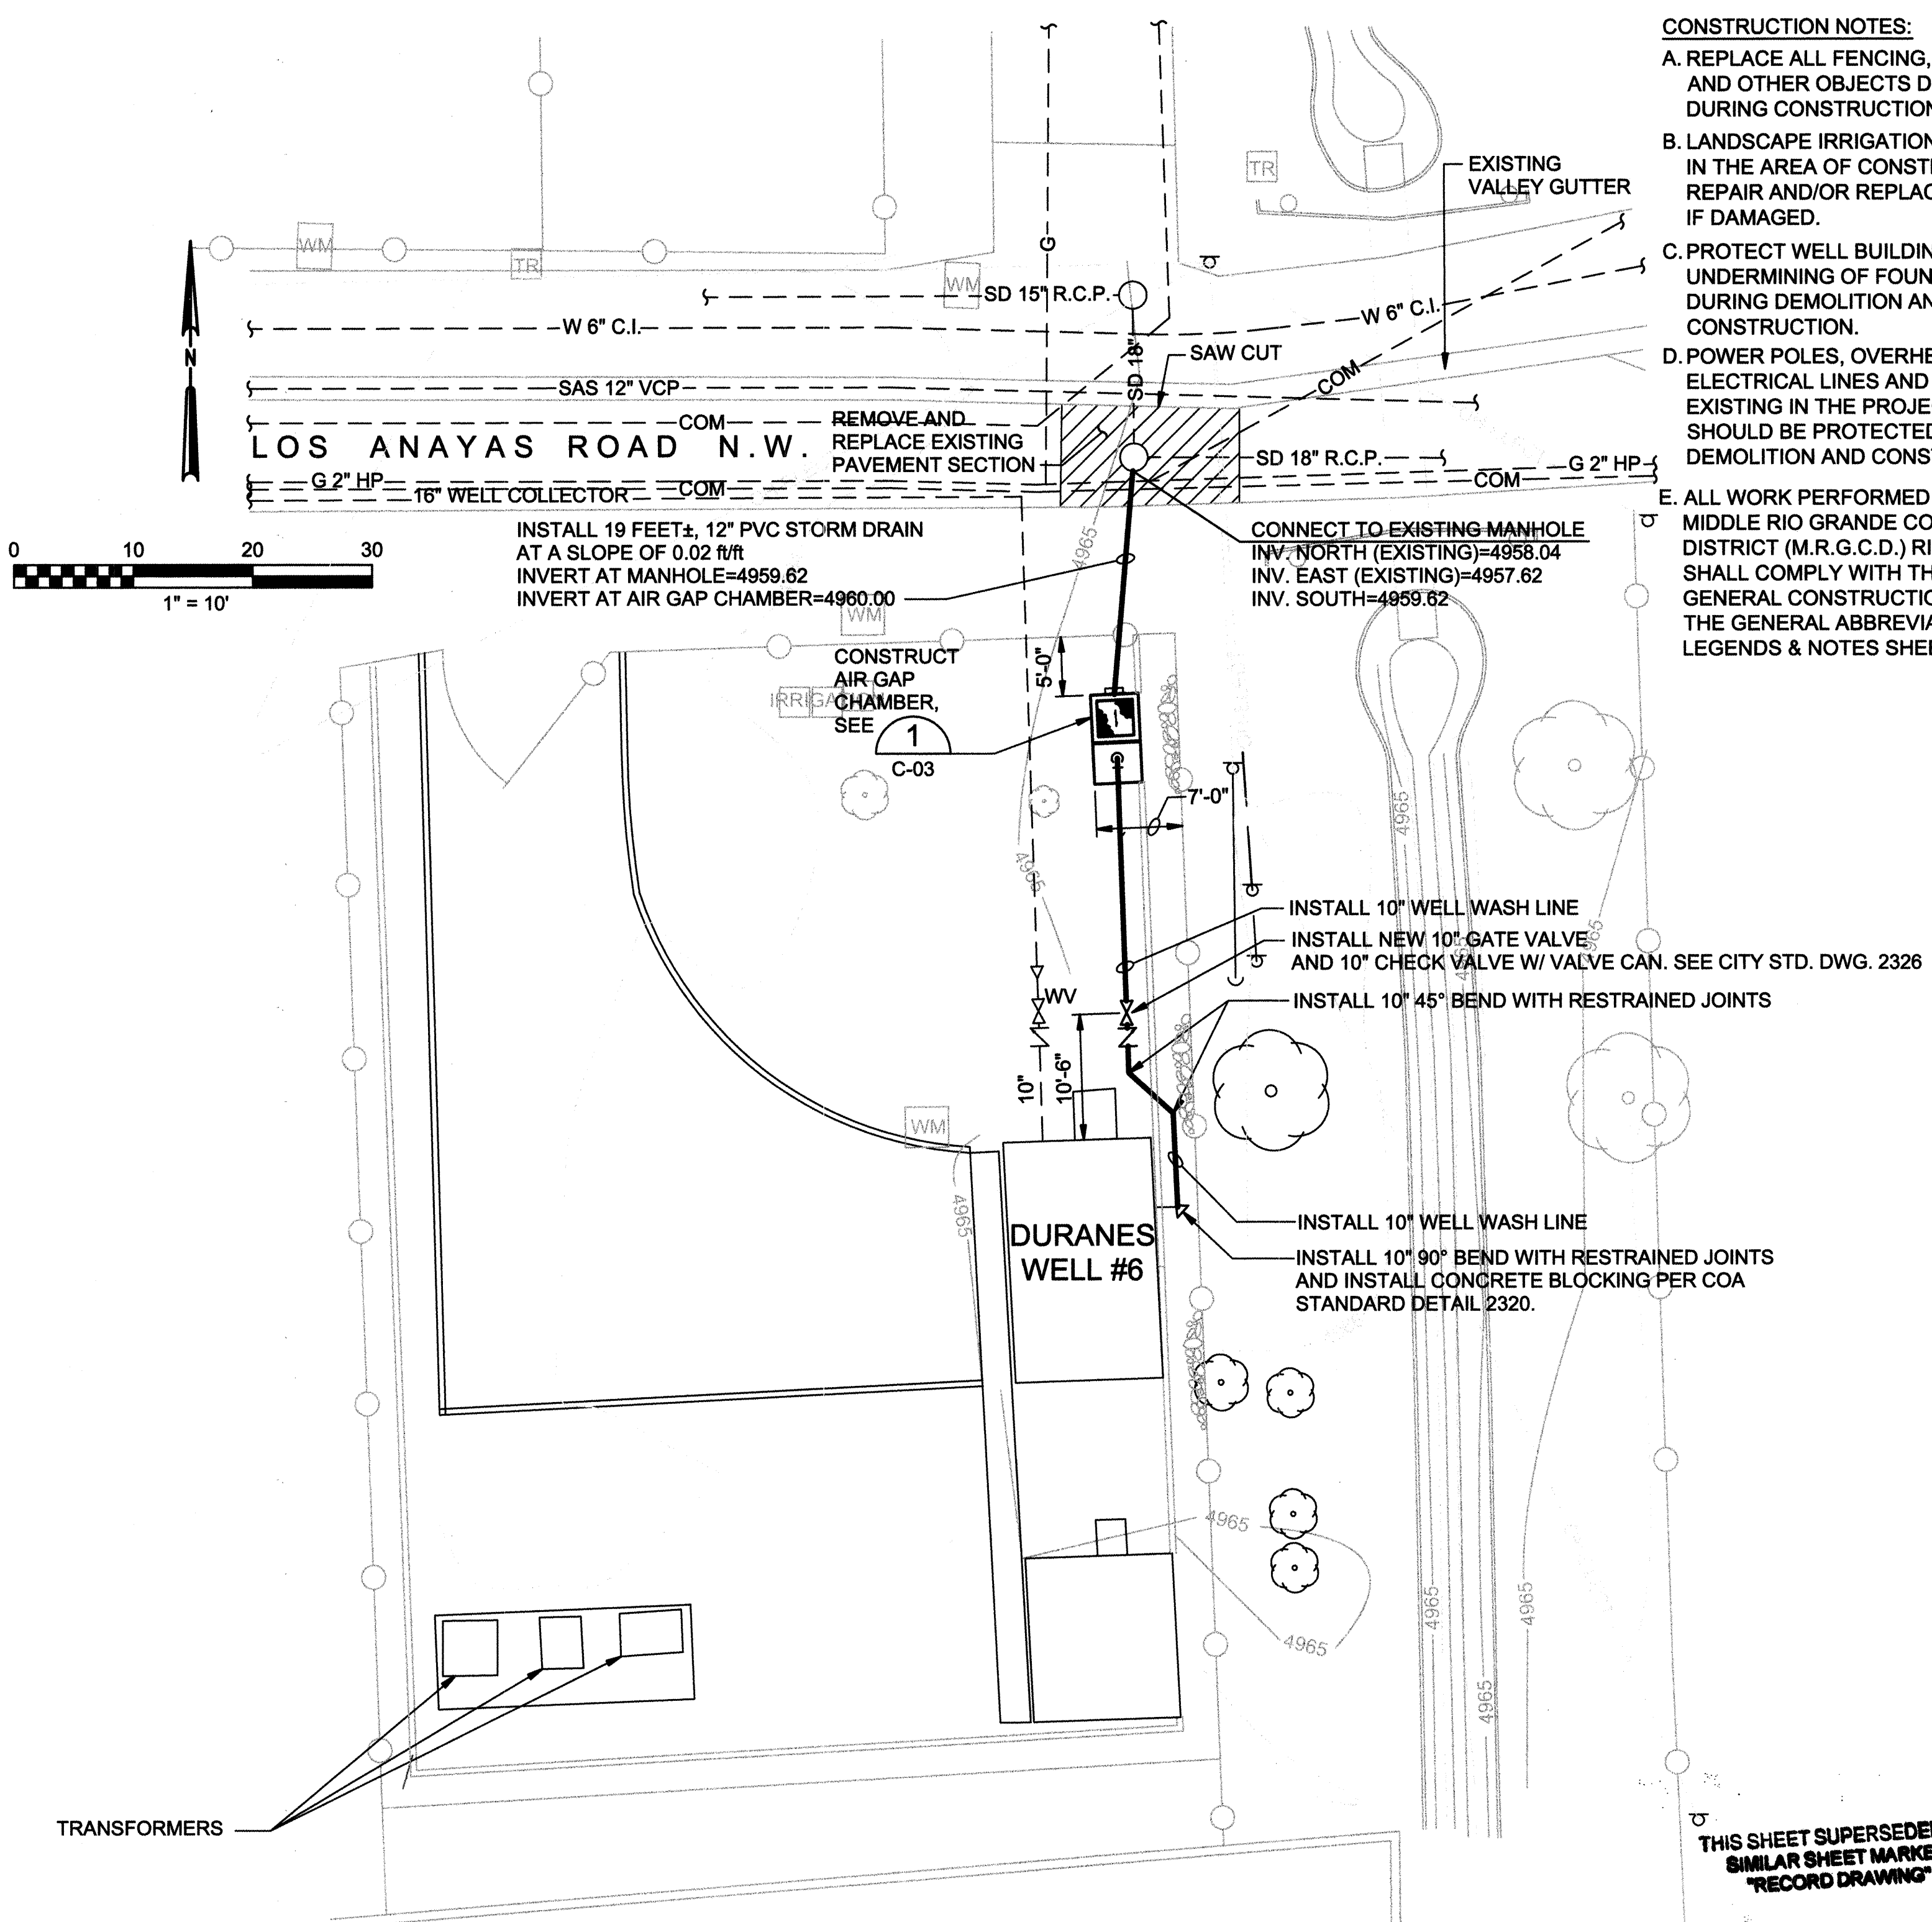

DURANES WELL #6 - SITE PLAN
1" = 10'-0"

- CONSTRUCTION NOTES:**
- REPLACE ALL FENCING, LANDSCAPING, AND OTHER OBJECTS DISTURBED DURING CONSTRUCTION.
 - LANDSCAPE IRRIGATION IS PRESENT IN THE AREA OF CONSTRUCTION. REPAIR AND/OR REPLACE IRRIGATION IF DAMAGED.
 - PROTECT WELL BUILDING TO PREVENT UNDERMINING OF FOUNDATION SLAB DURING DEMOLITION AND CONSTRUCTION.
 - POWER POLES, OVERHEAD ELECTRICAL LINES AND GUYWIRES EXISTING IN THE PROJECT AREA AND SHOULD BE PROTECTED DURING DEMOLITION AND CONSTRUCTION.
 - ALL WORK PERFORMED WITHIN THE MIDDLE RIO GRANDE CONSERVANCY DISTRICT (M.R.G.C.D.) RIGHT-OF-WAY SHALL COMPLY WITH THE M.R.G.C.D. GENERAL CONSTRUCTION NOTES ON THE GENERAL ABBREVIATIONS LEGENDS & NOTES SHEET 2 OF 18.

AS BUILT INFORMATION		BENCH MARKS		SURVEY INFORMATION		ENGINEER'S SEAL		REVISIONS		DESIGN		CHECKED BY	
CONTRACTOR	DATE	BM#1	LOCATED AT	NO.	DATE	BY	DATE	NO.	DATE	BY	DATE	NO.	DATE
NEW MEXICO UNDERGROUND CONSTRUCTION, INC.	04/02/07	BLVD. N.W. AND INDIAN SCHOOL RD. N.W. STATION IS AN	ACS BRASS TAPLET, STAMPED 7-H137. X-373.826.5787										
INSPECTED BY	CH2MHILL	Y=1.496.192.2271	EL=4.961.72										
VERIFICATION BY	CH2MHILL	INTERSECTION OF RIO GRANDE BLVD. N.W. AND MATTHEW	AVE. N.W. STATION IS AN ACS BRASS TAPLET, STAMPED										
DRAWN BY	CH2MHILL	"3-G12" X-373.008.3079	Y=1.489.083.8866										
RECORDED BY	CH2MHILL	HORIZ. NAD 27	VERT. SLD 29										

CH2MHILL
6001 Indian School Rd, N.E., SUITE 350
Albuquerque, New Mexico 87110
(505) 884-5600

Albuquerque Bernalillo County
Water Utility Authority


TITLE: DURANES WELLS 2, 3 AND 6 WASHLINE MODIFICATIONS
DURANES WELL #6 SITE PIPING / DEMOLITION PLAN

DESIGN REVIEW COMMITTEE	CITY ENGINEER APPROVAL	Mo./Day/Yr.	Mo./Day/Yr.
APPROVED SEP 26 2006 DESIGN REVIEW COMMITTEE	APPROVED SEP 26 2006 CITY ENGINEER		


CITY PROJECT NO. 7279-03 Zone Map No. H-12 SHEET 14 OF 16
DRAWING NO. 3-C-1



323454.BD.DP
323454_6-C-01.dwg
1=1
06/06/2007

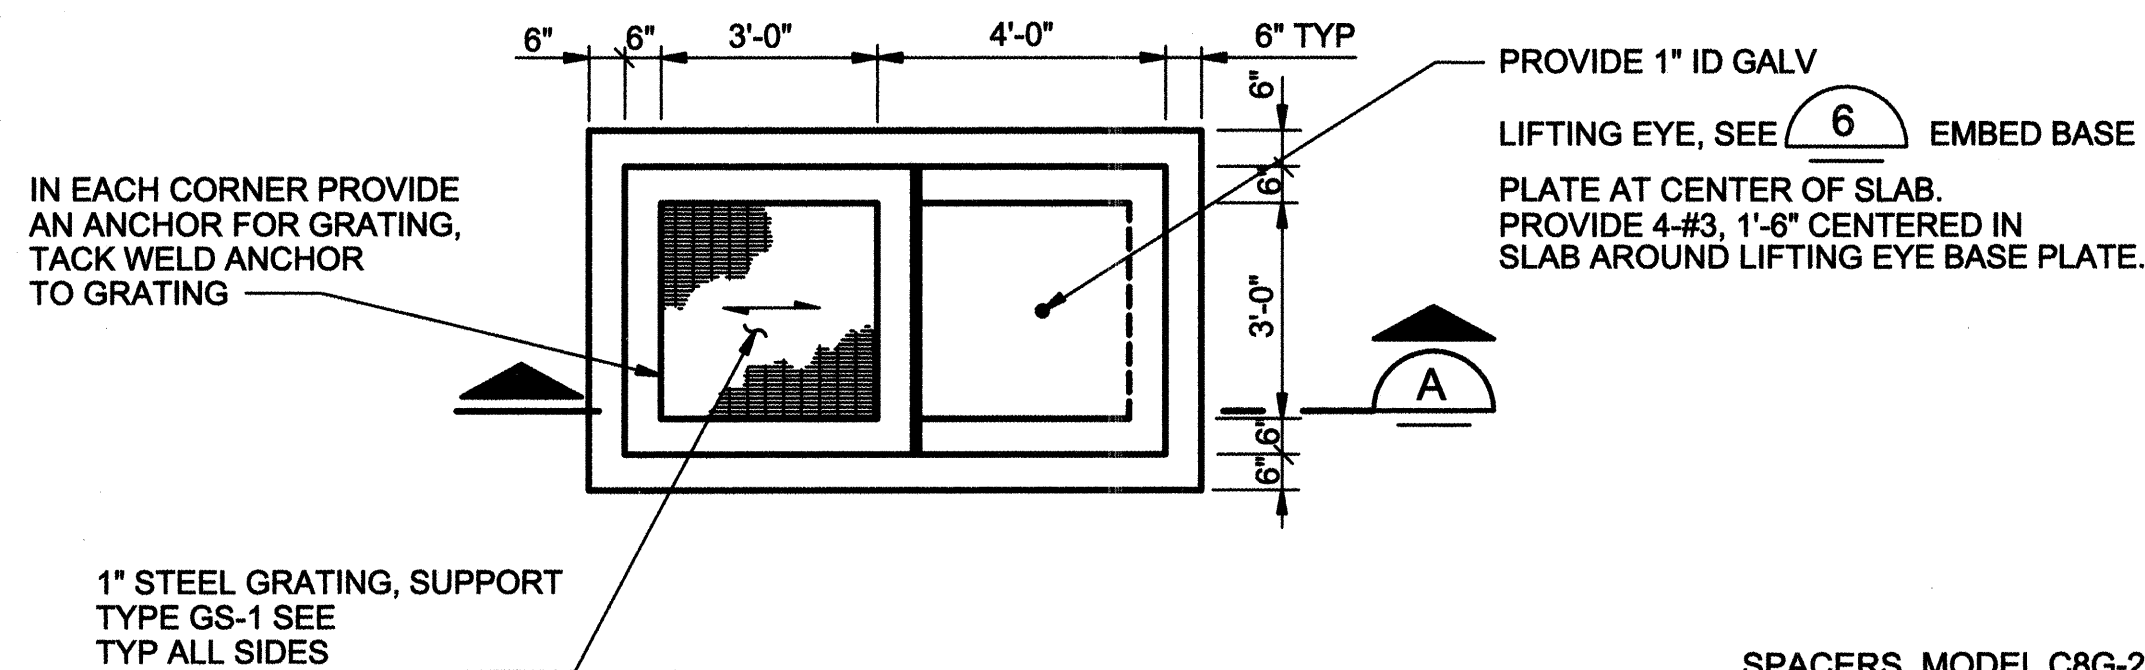


PLAN

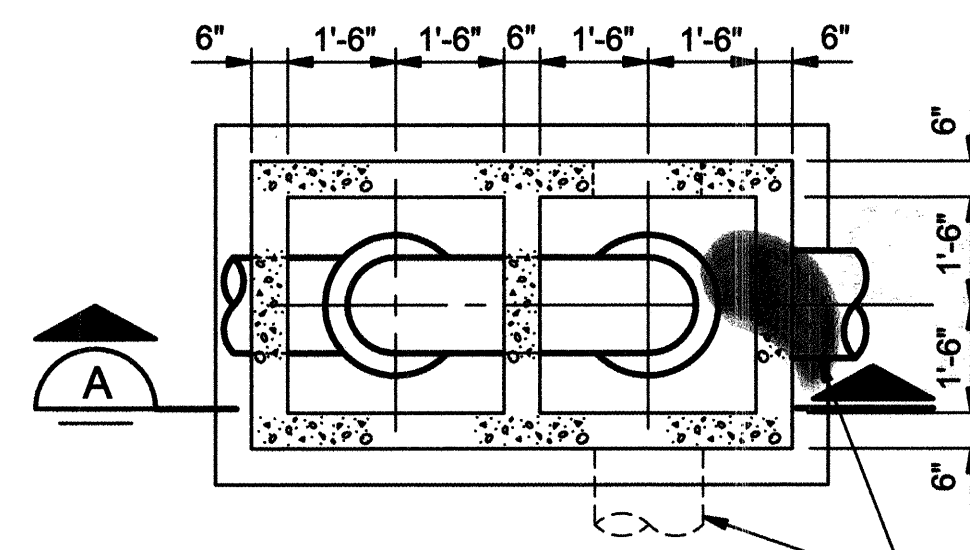

PLAN 1' BELOW TOP OF BOX

WELL SITE	a (INCHES) MINIMUM	FLOW (GPM)	PIPE DIA. (INCHES)			PIPE 3 INVERT ELEVATION (FT)	BOTTOM OF AIR GAP OPENING ELEVATION (FT)
			1	2	3		
DURANES WELL #2	28	2000	8	14	24	4962.49	4967.50
DURANES WELL #3	28	2300	12	14	24	4956.27	4962.66
DURANES WELL #6	24	1570	10	12	12	4960.00	4965.50

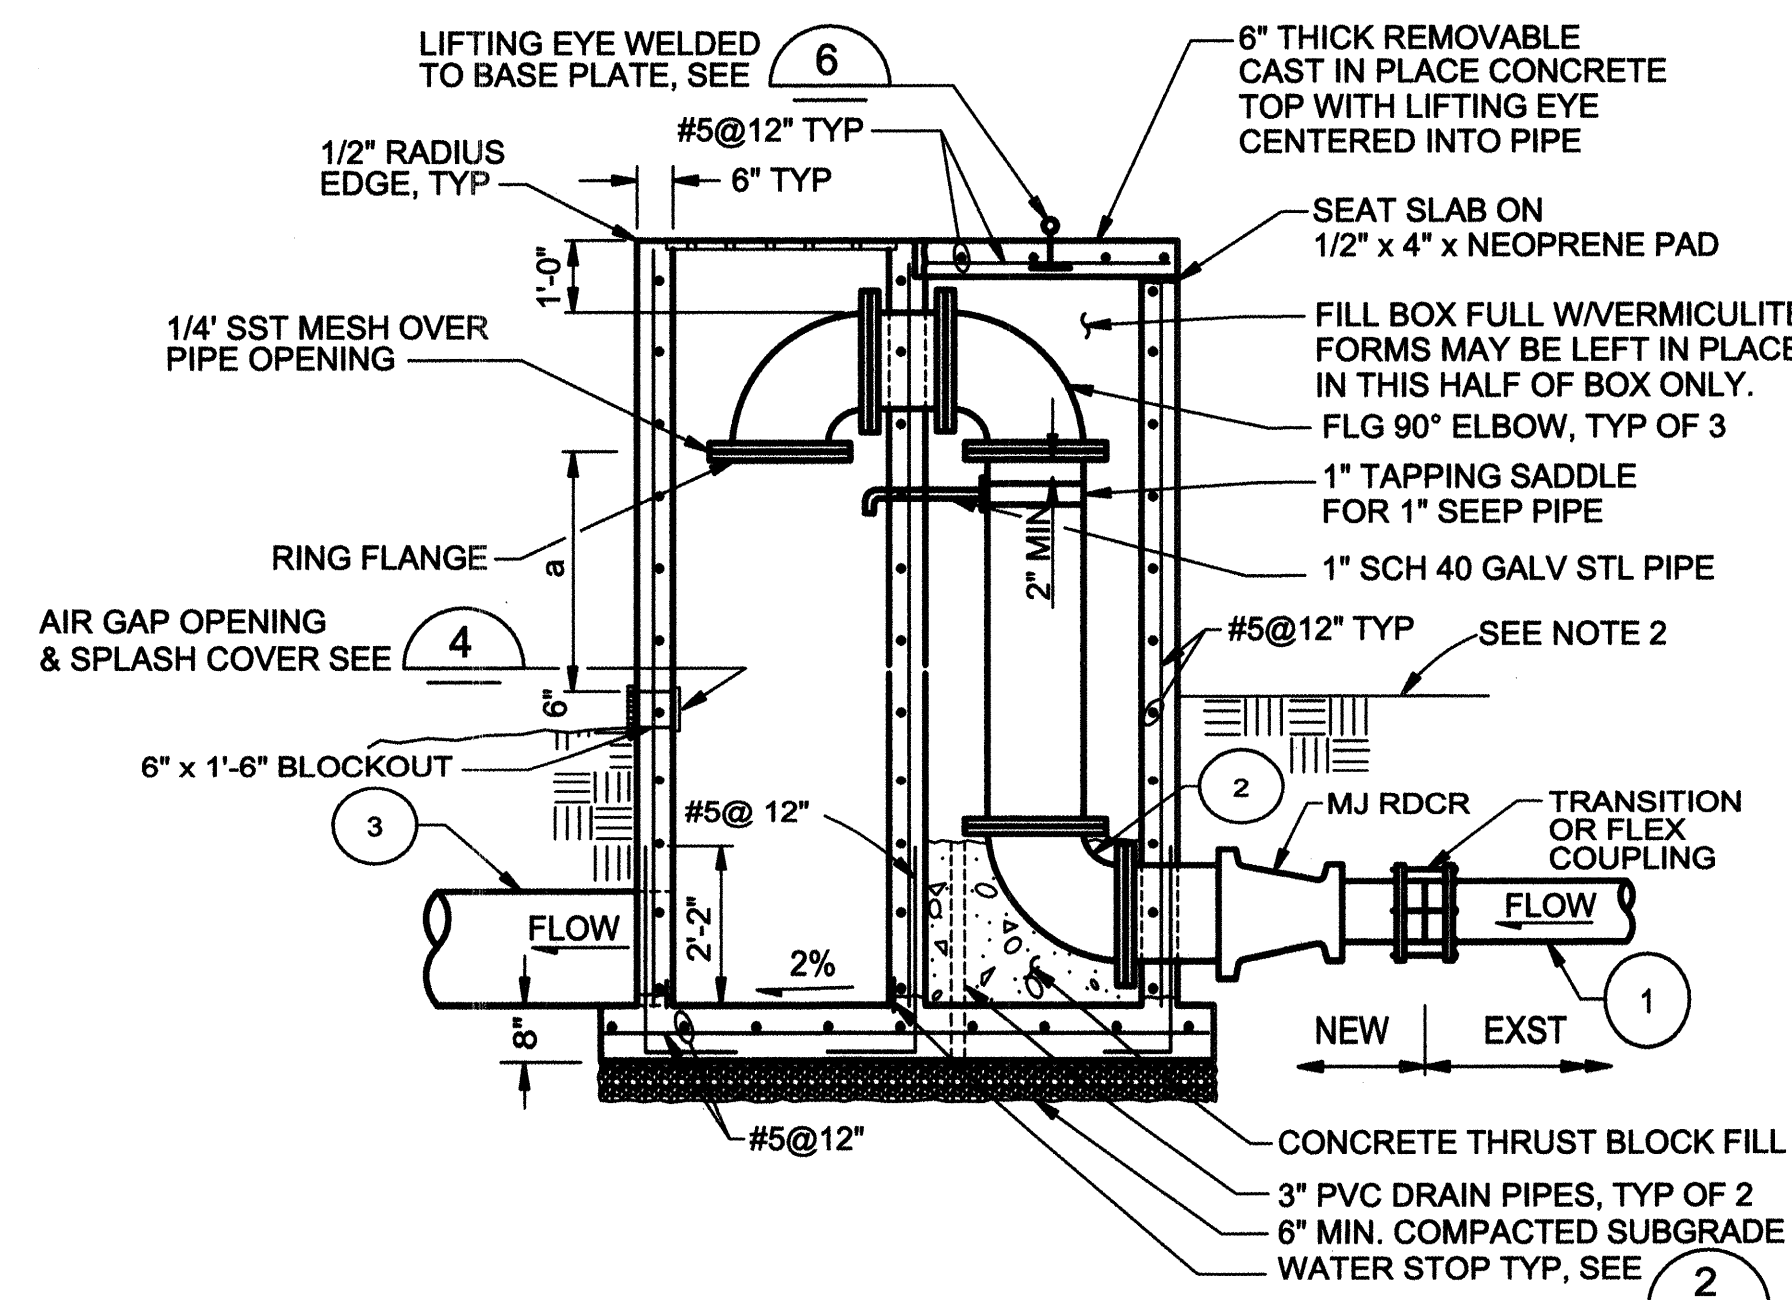

SECTION A

- NOTES:
1. AT CONTRACTOR'S OPTION, AIR GAP CHAMBER PIPING MAY BE WELDED STL.
 2. CHAMBER HEIGHT DEPENDENT ON OUTLET PIPE INVERT AND EXISTING GROUND ELEV. SEE WELL SITE PLAN AND PROFILE SHEETS FOR THESE ELEVATIONS.

AIR GAP CHAMBER

NTS

SPACERS, MODEL C8G-2 AS MANUFACTURED BY PIPELINE SEAL AND INSULATOR INC. OF HOUSTON TX. OR EQUAL


CARRIER PIPELINE AS SPECIFIED

STEEL CASING PIPE

UNDERCROSSING
SPACER DETAIL


N.T.S.

1-PP-2

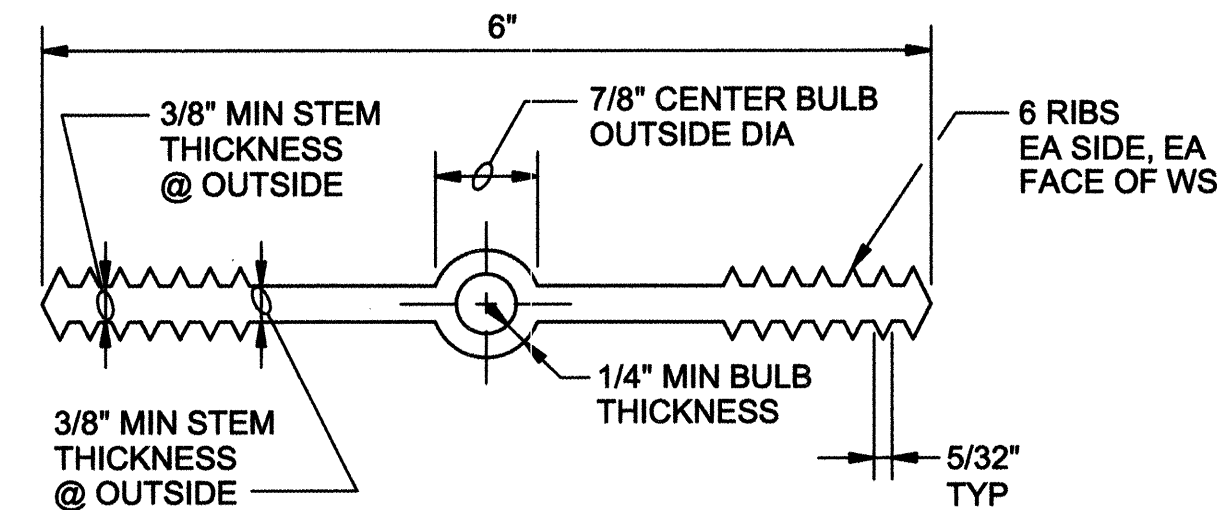


PLASTIC WATERSTOP 2

NTS

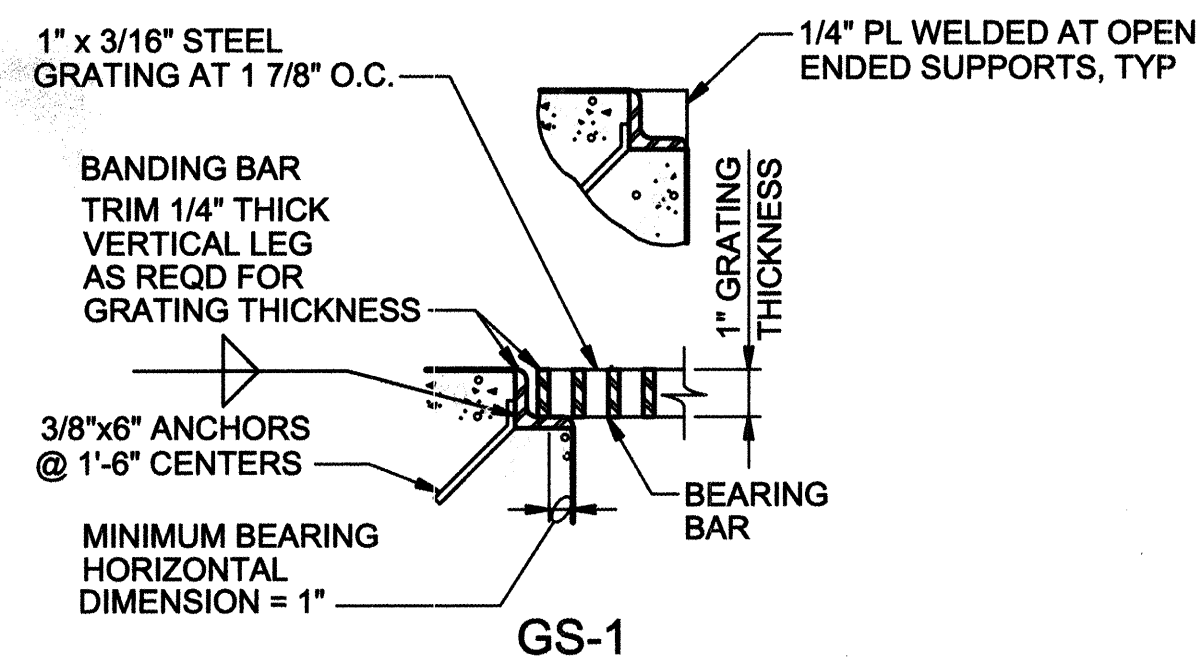

GRATING SUPPORT 3


NTS

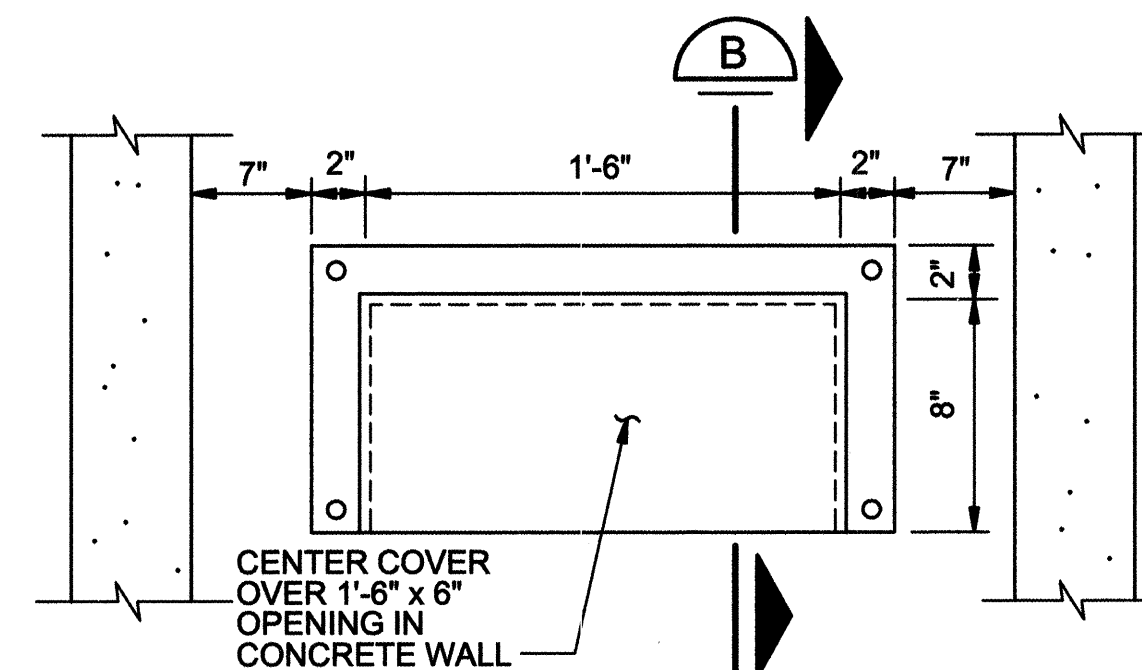

SECTION B

SPLASH COVER 4

NTS

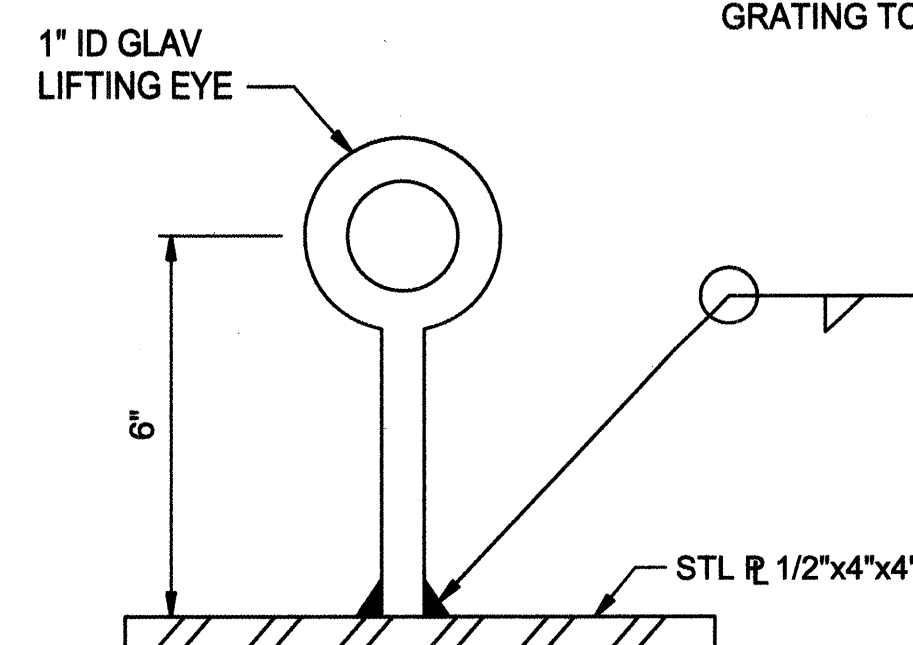

LIFTING EYE DETAIL 6

N.T.S.

GRATING NOTES:

1. GRATING SPAN — SEE PLAN. SHOP DRAWINGS BASED ON FIELD DIMENSIONS SHALL BE SUBMITTED TO THE ENGINEER PRIOR TO FABRICATION. MATERIAL FOR METAL SUPPORTS OF STEEL SHALL BE GALVANIZED STEEL.
2. BEARING BAR THICKNESS FOR GRATING TO BE 3/16" MINIMUM.
3. BAND ALL EDGES WITH 3/16"x DEPTH OF BEARING BAR.
4. PROVIDE MISCELLANEOUS GRATING FASTENERS AS REQUIRED.
5. THE HORIZONTAL CLEARANCE BETWEEN THE GRATING AND GRATING SUPPORTS SHALL NOT BE LESS THAN 1/4" NOR GREATER THAN 1/2".
6. ALL GRATING SECTIONS, WHEN IN PLACE, SHALL ALWAYS BE FIRMLY ANCHORED TO THEIR SUPPORTS.

GENERAL STRUCTURAL NOTES:

1. MINIMUM CLEARANCE FOR REINFORCEMENT BARS, SHALL BE 3" WHEN PLACED ON GROUND, FOR SURFACES EXPOSED TO WATER OR WEATHER: 1 1/2" CLEARANCE FOR #5 BAR AND SMALLER AND 2" CLEARANCE FOR LARGER BARS. INTERIOR SLABS 3/4" CLEARANCE, INTERIOR BEAMS 1 1/2" CLEARANCE.
2. ALL WALL REINFORCEMENT BARS SHALL BE CONTINUOUS AROUND CORNERS AND THOUGH COLUMNS OR PILASTERS. REINFORCEMENT BARS SHALL BE EXTENDED INTO CONNECTING WALLS. VERTICAL WALL BARS SHALL BE LAPPED WITH DOWELS FROM BASE SLABS.
3. ALL REINFORCEMENT BENDS AND LAPS, UNLESS OTHERWISE NOTED SHALL SATISFY THE FOLLOWING MINIMUM REQUIREMENT:

REINFORCEMENT LAP DISTANCE (DIMENSIONS IN INCHES)										
	BAR SIZE	#3	#4	#5	#6	#7	#8	#9	#10	#11
SPACING < 6"	TOP BAR	21	29	36	46	62	82	104	132	163
	OTHER BAR	15	20	26	33	45	59	74	95	116
SPACING > 6"	TOP BAR	17	23	29	37	50	66	83	106	130
	OTHER BAR	12	16	20	26	36	47	60	76	93

4. PROVIDE AND INSTALL 6" THICK OF COMPACTED SUBGRADE MATERIAL (95% COMPACTION) UNDER ALL SLABS.
5. ALL EMBEDDED PIPING, TUBING, ANCHOR BOLTS, AND OTHER EMBEDDED ITEMS SHALL BE SUPPORTED TO PROVIDE A MINIMUM OF 1" CLEARANCE FROM ALL REINFORCING.
6. ALL STRUCTURAL CONCRETE SHALL HAVE A MINIMUM COMPRESSION STRENGTH OF 4000 psi.
7. REINFORCING STEEL SHALL HAVE A YIELD STRENGTH OF 60,000 psi.

RECORD DRAWINGS

These RECORD DRAWINGS HAVE BEEN PREPARED, IN PART, ON THE BASIS OF INFORMATION COMPILED BY OTHERS. THEY ARE NOT INTENDED TO REPRESENT IN DETAIL THE EXACT LOCATION, TYPE OF COMPONENT NOR MANNER OF CONSTRUCTION. THE ENGINEER WILL NOT BE RESPONSIBLE FOR ANY ERRORS OR OMISSIONS WHICH HAVE BEEN INCORPORATED INTO THE RECORD DRAWINGS.

CH2MHILL

6001 Indian School Rd, N.E., SUITE 350
Albuquerque, New Mexico 87110
(505) 884-5600



Albuquerque Bernalillo County
Water Utility Authority


TITLE: DURANES WELLS 2, 3 AND 6 WASHLINE MODIFICATIONS
MISCELLANEOUS DETAILS - AIR GAP CHAMBER

Design Review Committee	City Engineer Approval	Mo./Day/Yr.	Mo./Day/Yr.
APPROVE SEP 26 2006 DESIGN REVIEW COMMITTEE	APPROVE SEP 26 2006 CITY ENGINEER		

CITY PROJECT NO. 7279-03 Zone Map No. SHEET 15 OF 16
DRAWING NO. 4-M-1


NOTES: 1. PROVIDE 12" PREPARED SUBGRADE, COMPACT TO 95% BENEATH SIDEWALKS OR BIKE PATHS.

2. ALL EXCAVATIONS, IN EXCESS OF 20 FT. DEEP SHALL BE DESIGNED BY A PROFESSIONAL ENGINEER REGISTERED IN THE STATE OF N.M.

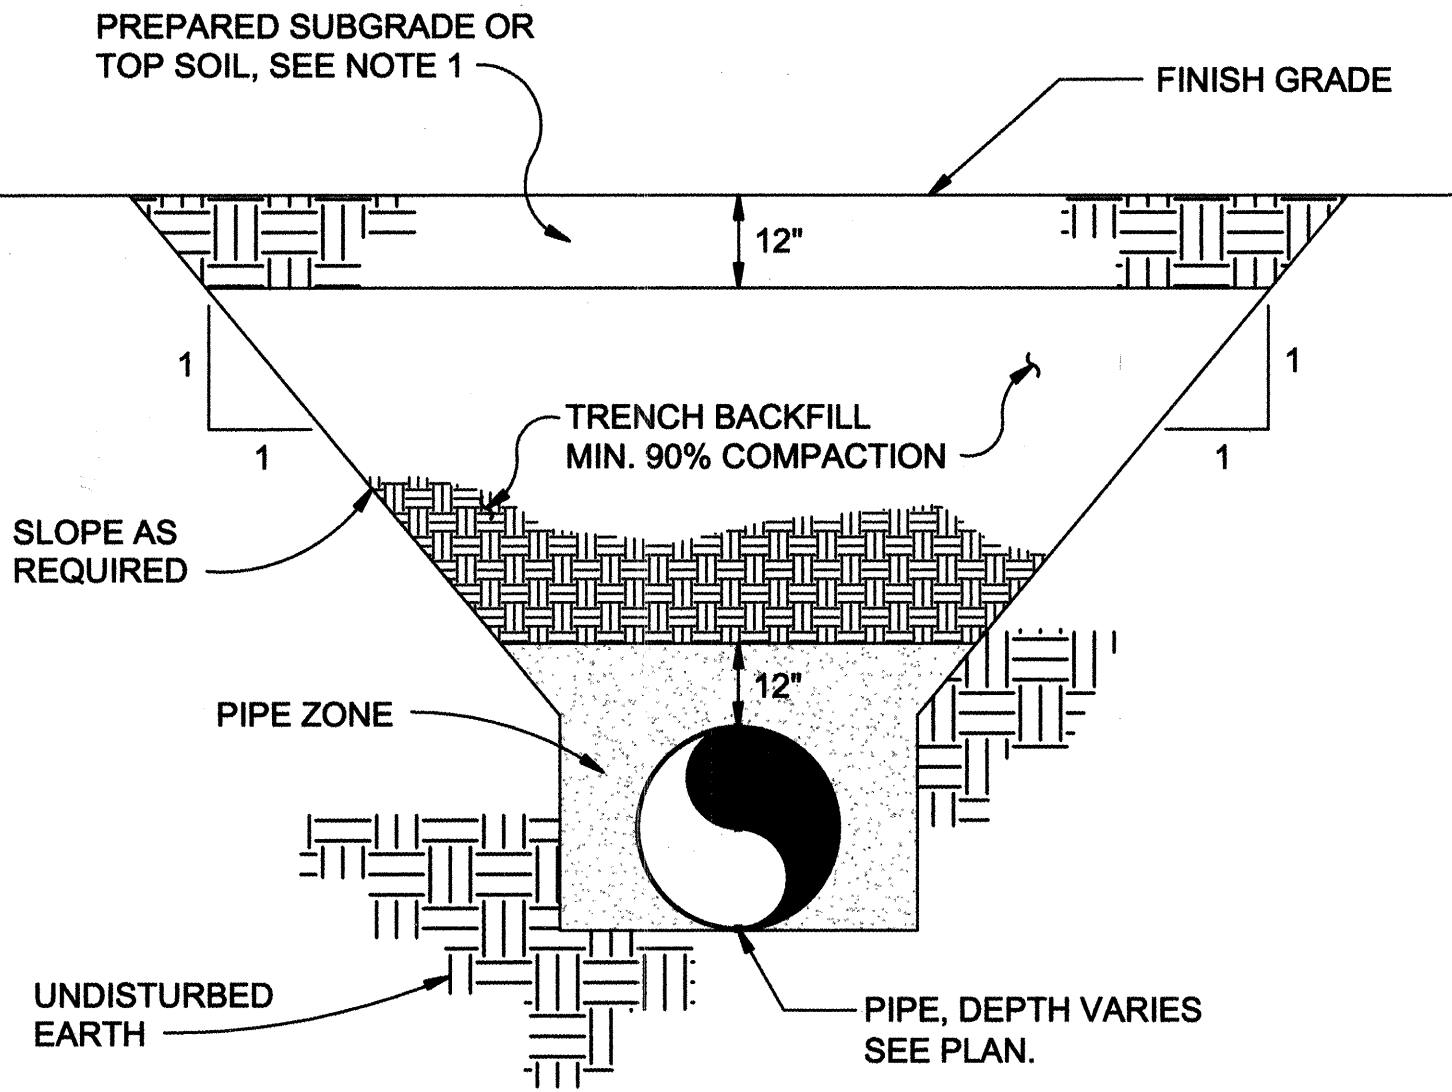

TYPICAL TRENCH DETAIL OUTSIDE ROADWAY 1

N.T.S.

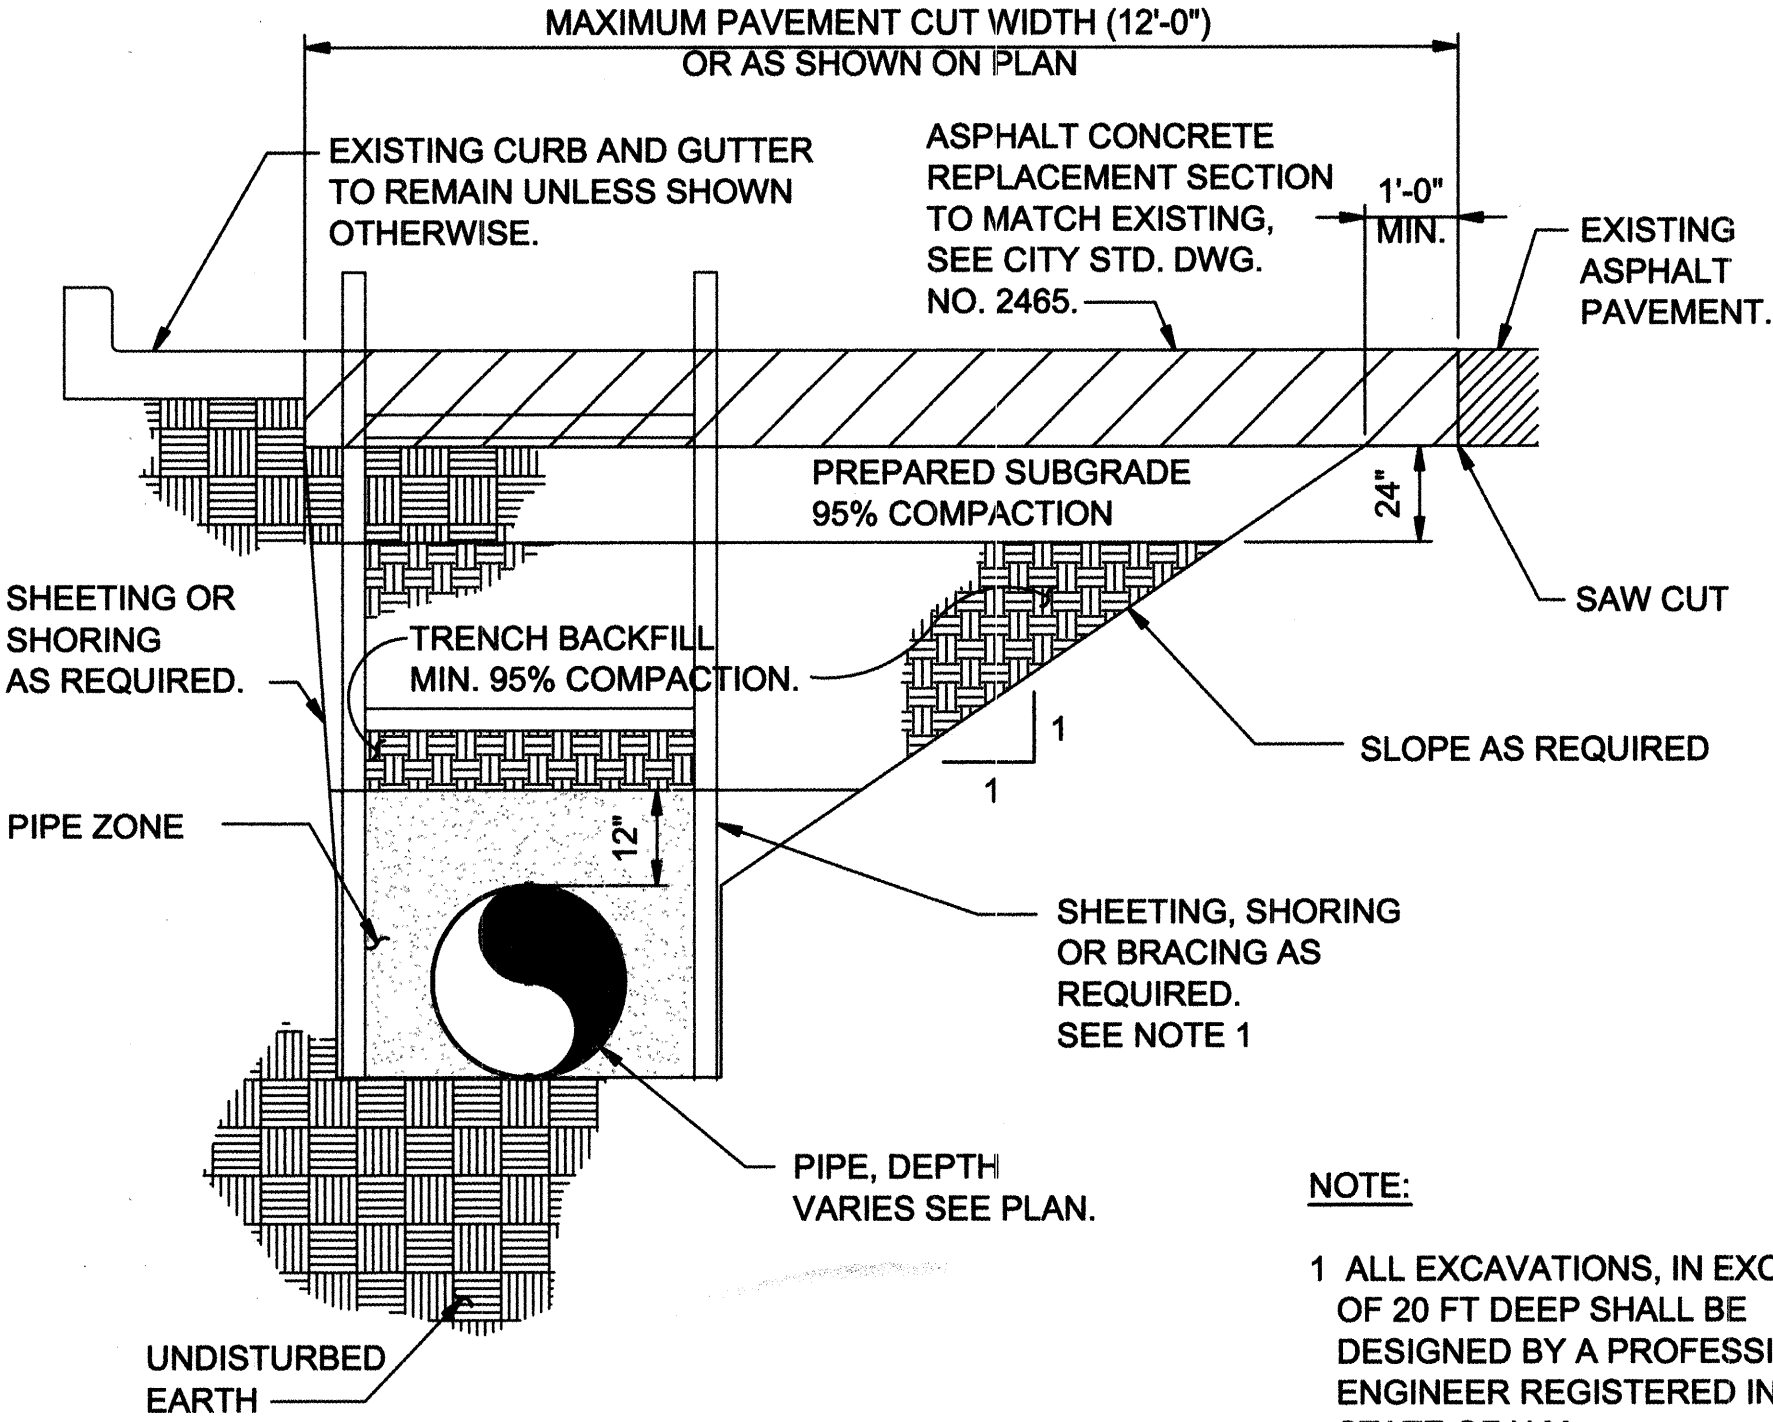

NOTE:

1. ALL EXCAVATIONS, IN EXCESS OF 20 FT DEEP SHALL BE DESIGNED BY A PROFESSIONAL ENGINEER REGISTERED IN THE STATE OF N.M.

TYPICAL TRENCH DETAIL INSIDE ROADWAY 2

N.T.S.

RECORD DRAWINGS

Revisions Drawn by EJA Date 01/2007

THESE RECORD DRAWINGS HAVE BEEN PREPARED, IN PART, ON THE BASIS OF INFORMATION COMPILED BY OTHERS. THEY ARE NOT INTENDED TO REPRESENT IN DETAIL THE EXACT LOCATION, TYPE OF COMPONENT AND MANNER OF CONSTRUCTION. THE ENGINEER WILL NOT BE RESPONSIBLE FOR ANY ERRORS OR OMISSIONS WHICH HAVE BEEN INCORPORATED INTO THE RECORD DRAWINGS.

CH2MHILL

6001 Indian School Rd, N.E., SUITE 350
Albuquerque, New Mexico 87110
(505) 884-5600

Albuquerque Bernalillo County
Water Utility Authority

TITLE: DURANES WELLS 2, 3 AND 6 WASHLINE MODIFICATIONS
MISCELLANEOUS DETAILS - TRENCH SECTIONS

Design Review Committee	City Engineer Approval	Mo./Day/Yr.	Mo./Day/Yr.
APPROVED SEP 26 2006 DESIGN REVIEW COMMITTEE	APPROVED SEP 26 2006 CITY ENGINEER		

CITY PROJECT NO. 7279-03
Zone Map No. -
SHEET 16 OF 16
DRAWING NO. 4-M-2