
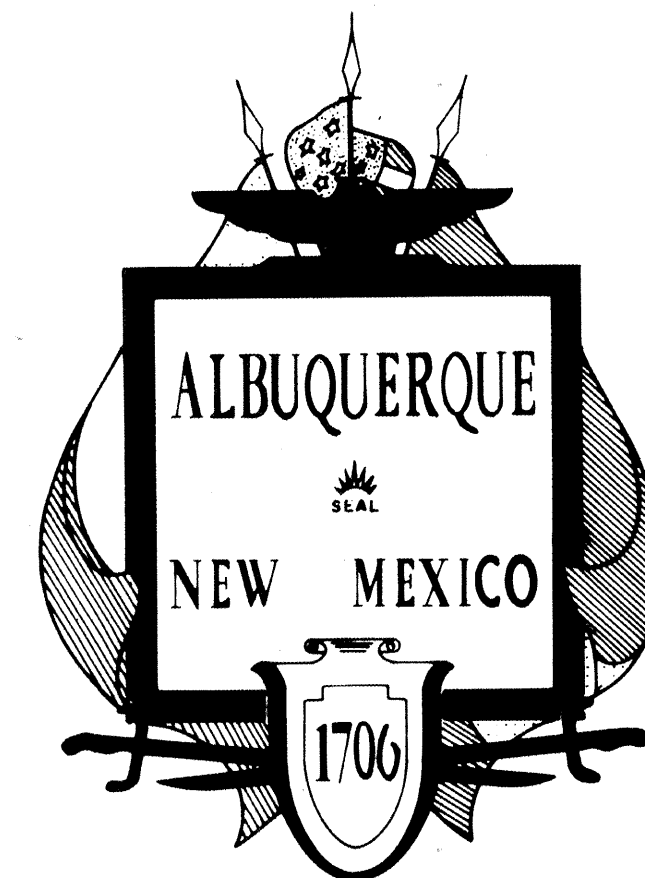


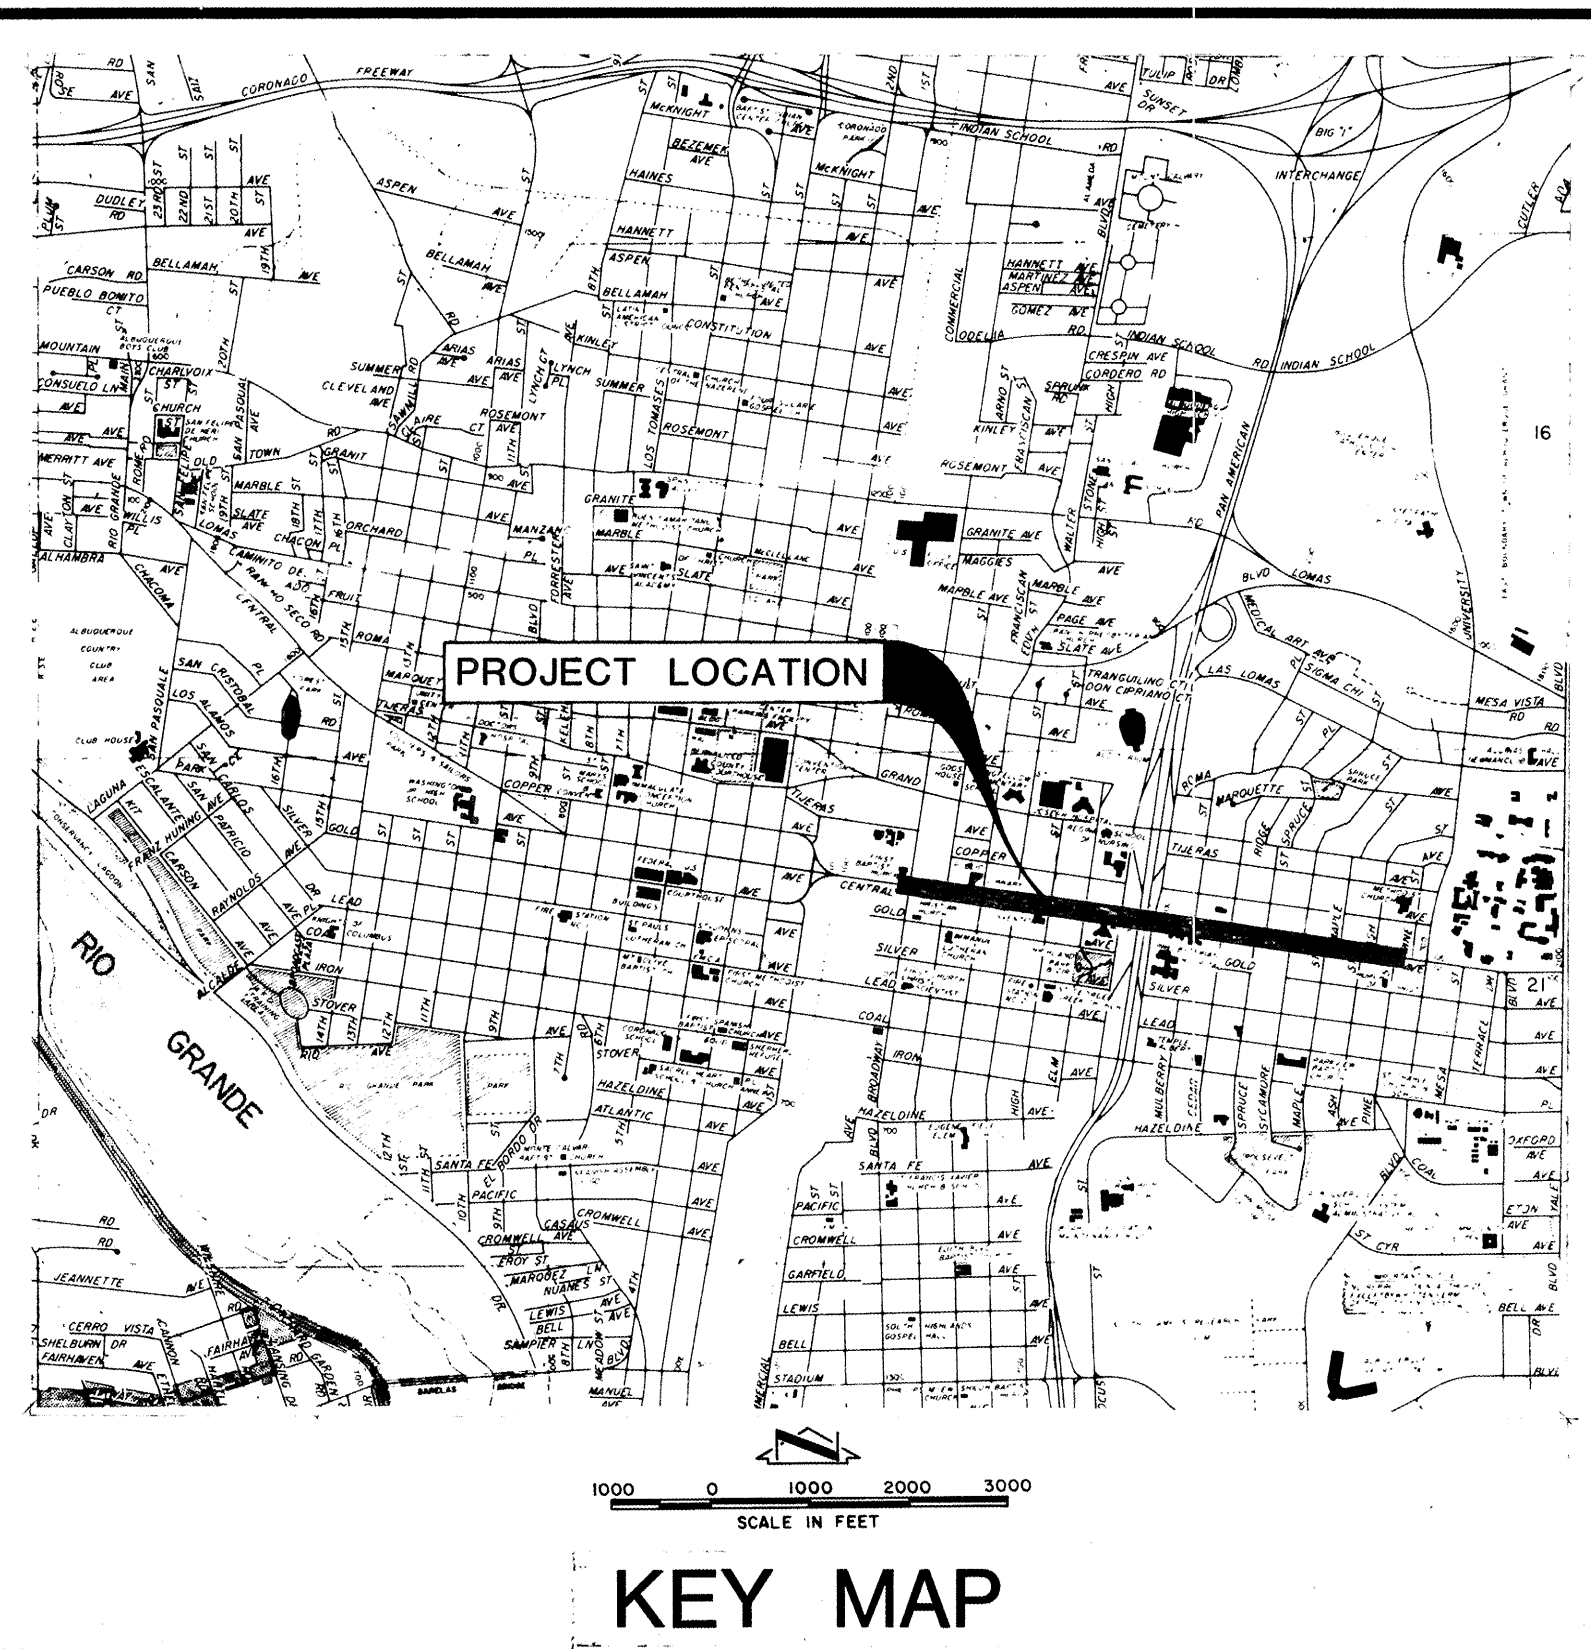

CITY OF ALBUQUERQUE, NEW MEXICO

INDEX TO SHEETS

Description	Sheet
COVER SHEET	1
LEGEND, ABBREVIATIONS and GENERAL NOTES	2 *
SURVEY CONTROL	3 *
SEQUENCE of CONSTRUCTION	4 *
LINE A PLAN and PROFILE	5 - 9
LINE B PLAN and PROFILE	10 - 12, 14 - 15
LINE C PLAN and PROFILE	10 - 11
LINE D PLAN and PROFILE	13
LINE E PLAN and PROFILE	14 - 15
LINE B-1 PLAN and PROFILE	16 - 17
LINE B-8 PLAN and PROFILE	18 - 19
LINE B-8.1 PLAN and PROFILE	20 - 21

* SHEETS NOT INCLUDED IN THIS SET OF PLANS. THESE SHEETS WERE INCLUDED IN A SET OF PAVING PLANS BY DENNEY GROSS & ASSOCIATES. SHEETS HAVE BEEN RENUMBERED TO CORRESPOND TO NUMBERING SEQUENCE OF DENNEY GROSS PLANS.

STEEL WATER LINE REPLACEMENT

PHASE I B

CENTRAL AVENUE

BROADWAY BOULEVARD TO UNIVERSITY BOULEVARD

Set Number _____

JOB NO. 79038

City Engineer

David R. Brosman
Project Engineer




SCANLON & ASSOCIATES
CONSULTING ENGINEERS



PLAN	DATE
SURVEYED	
NOTED	
GRADES CHECKED	
STRUCTURE NOTED	
NO.	

SCANNED BY
MESA REPRO


PROFILE	DATE
SURVEYED	
NOTED	
GRADES CHECKED	
STRUCTURE NOTED	
NO.	

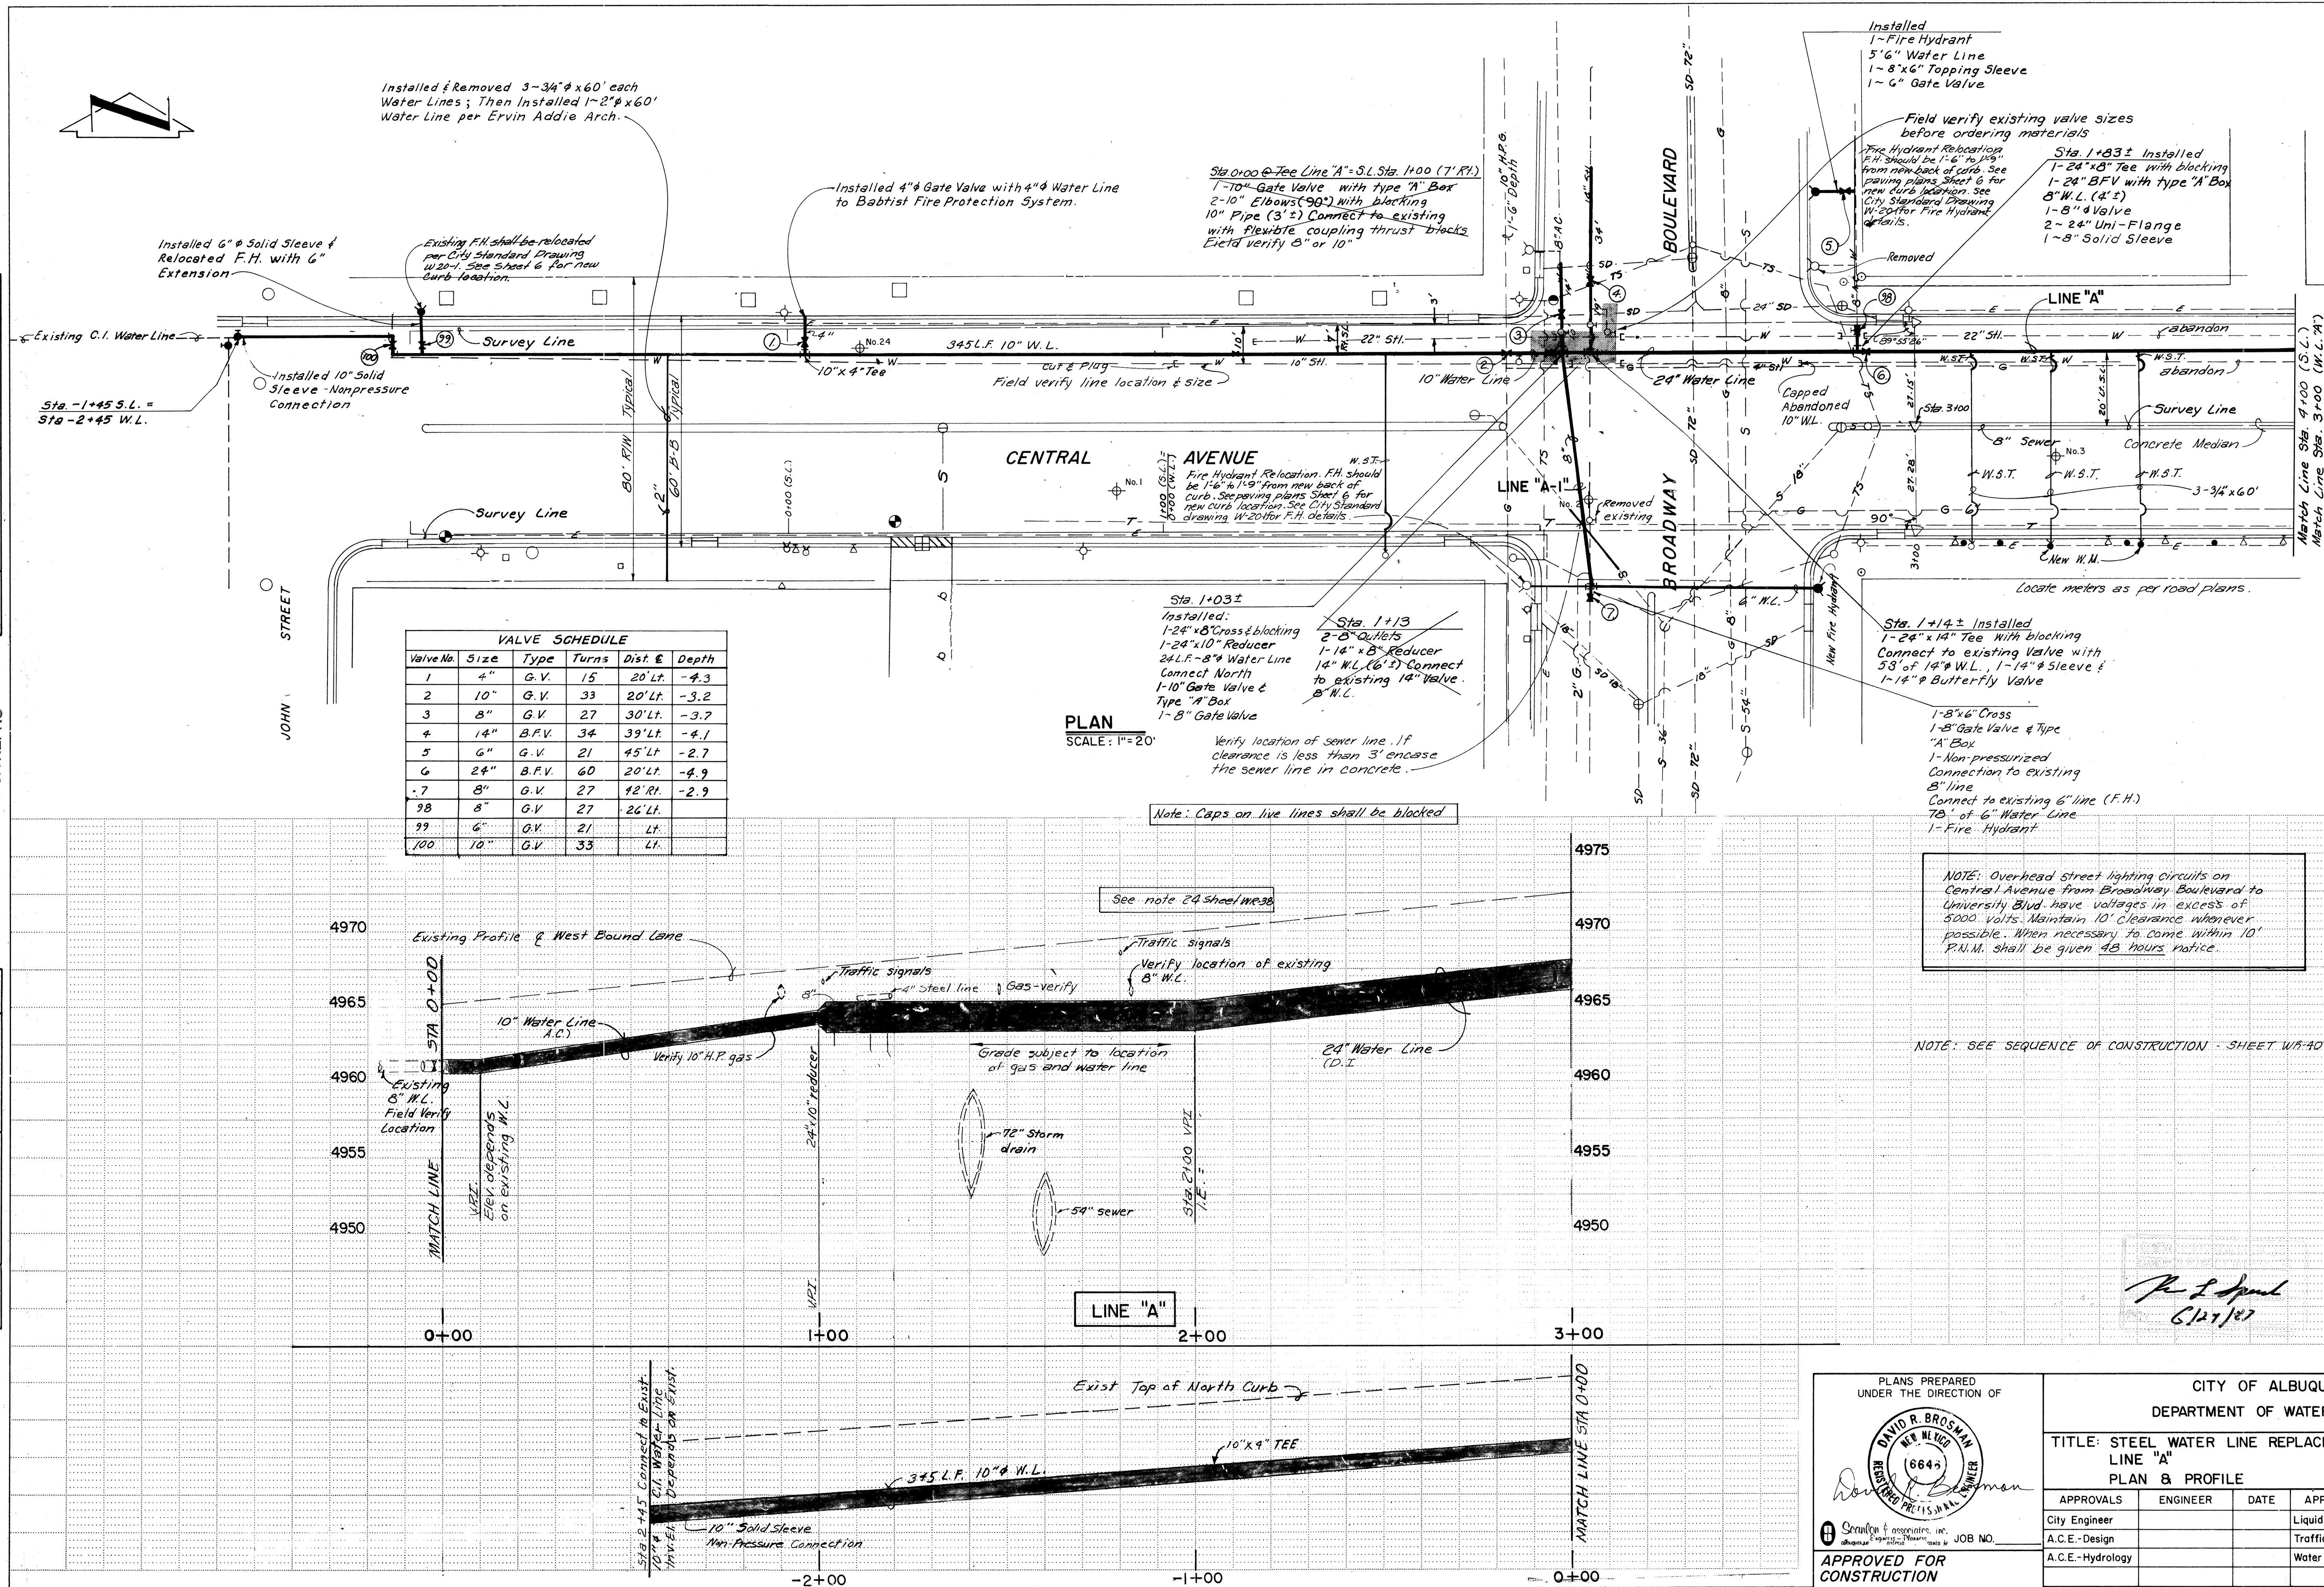


PLANS PREPARED UNDER THE DIRECTION OF 		CITY OF ALBUQUERQUE DEPARTMENT OF WATER RESOURCES TITLE: STEEL WATER LINE REPLACEMENT - PHASE 1B LINE "A" PLAN & PROFILE	
APPROVALS	ENGINEER	DATE	APPROVALS
City Engineer			Liquid Waste
A.C.E.-Design			Traffic
A.C.E.-Hydrology			Water
APPROVED FOR CONSTRUCTION CITY ENGINEER		DATE	
DRAWING NO. <i>Refer to Project 1736</i>		SHEET 41 OF 63 WR	

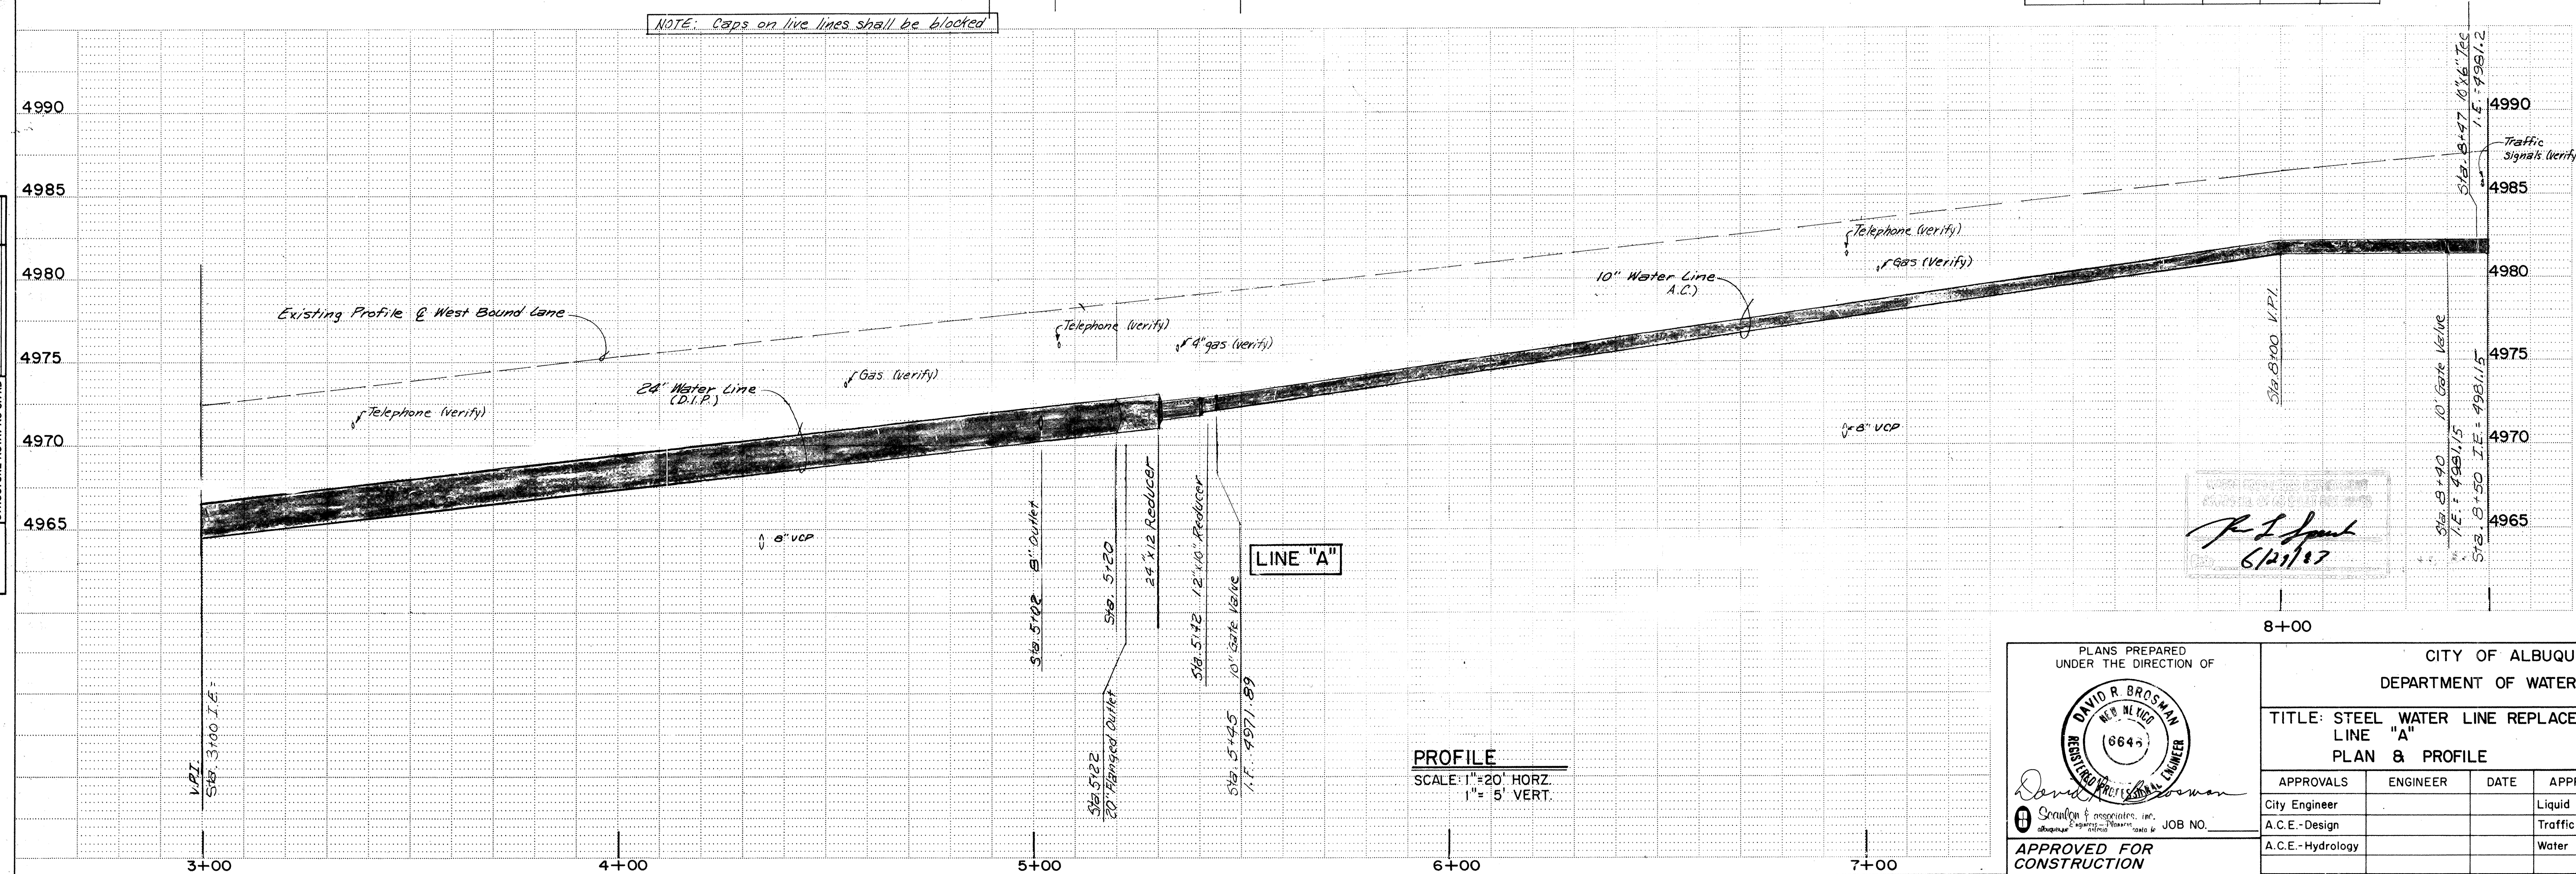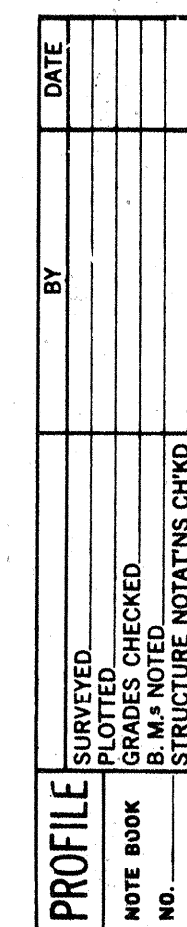


Valve No.	Size	Type	Turns	Dist. £	Depth
8	8"	G.V.	27	50' Lt.	-1.5'
9	2 1/2"	B.F.V.	60	50' Lt.	-3.9
10	6"	G.V.	21	40' Rt.	-3.5
11	10"	G.V.	33	20' Lt.	-3.6
12	10"	G.V.	33	20' Lt.	-3.1
13	6"	G.V.	21	30' Lt.	-3.7

 PLANS PREPARED UNDER THE DIRECTION OF  <i>David H. Scriffan</i> David H. Scriffan & Associates, Inc. Albuquerque, New Mexico JOB NO. _____ APPROVED FOR CONSTRUCTION CITY ENGINEER _____ DATE _____	CITY OF ALBUQUERQUE DEPARTMENT OF WATER RESOURCES TITLE: STEEL WATER LINE REPLACEMENT - PHASE 1B LINE "A" PLAN & PROFILE																														
	<table border="1" style="width: 100%; border-collapse: collapse;"> <tr> <th style="width: 33%;">APPROVALS</th> <th style="width: 33%;">ENGINEER</th> <th style="width: 33%;">DATE</th> <th style="width: 33%;">APPROVALS</th> <th style="width: 33%;">ENGINEER</th> <th style="width: 33%;">DATE</th> </tr> <tr> <td>City Engineer</td> <td></td> <td></td> <td>Liquid Waste</td> <td></td> <td></td> </tr> <tr> <td>A.C.E. - Design</td> <td></td> <td></td> <td>Traffic</td> <td></td> <td></td> </tr> <tr> <td>A.C.E. - Hydrology</td> <td></td> <td></td> <td>Water</td> <td></td> <td></td> </tr> <tr> <td></td> <td></td> <td></td> <td></td> <td></td> <td></td> </tr> </table>	APPROVALS	ENGINEER	DATE	APPROVALS	ENGINEER	DATE	City Engineer			Liquid Waste			A.C.E. - Design			Traffic			A.C.E. - Hydrology			Water								
APPROVALS	ENGINEER	DATE	APPROVALS	ENGINEER	DATE																										
City Engineer			Liquid Waste																												
A.C.E. - Design			Traffic																												
A.C.E. - Hydrology			Water																												
	<table border="1" style="width: 100%; border-collapse: collapse;"> <tr> <td style="width: 70%;">DRAWING NO.</td> <td style="width: 30%; text-align: center;"> SHEET 42 OF 63 WR </td> </tr> </table>	DRAWING NO.	SHEET 42 OF 63 WR																												
DRAWING NO.	SHEET 42 OF 63 WR																														

PROFILE	SURVEYED	BY	DATE
	PLOTTED		
	GRADES CHECKED		
	B. M.'S NOTED		
	STRUCTURE NOTATIONS CHK'D		
NOTE BOOK			
NO.			


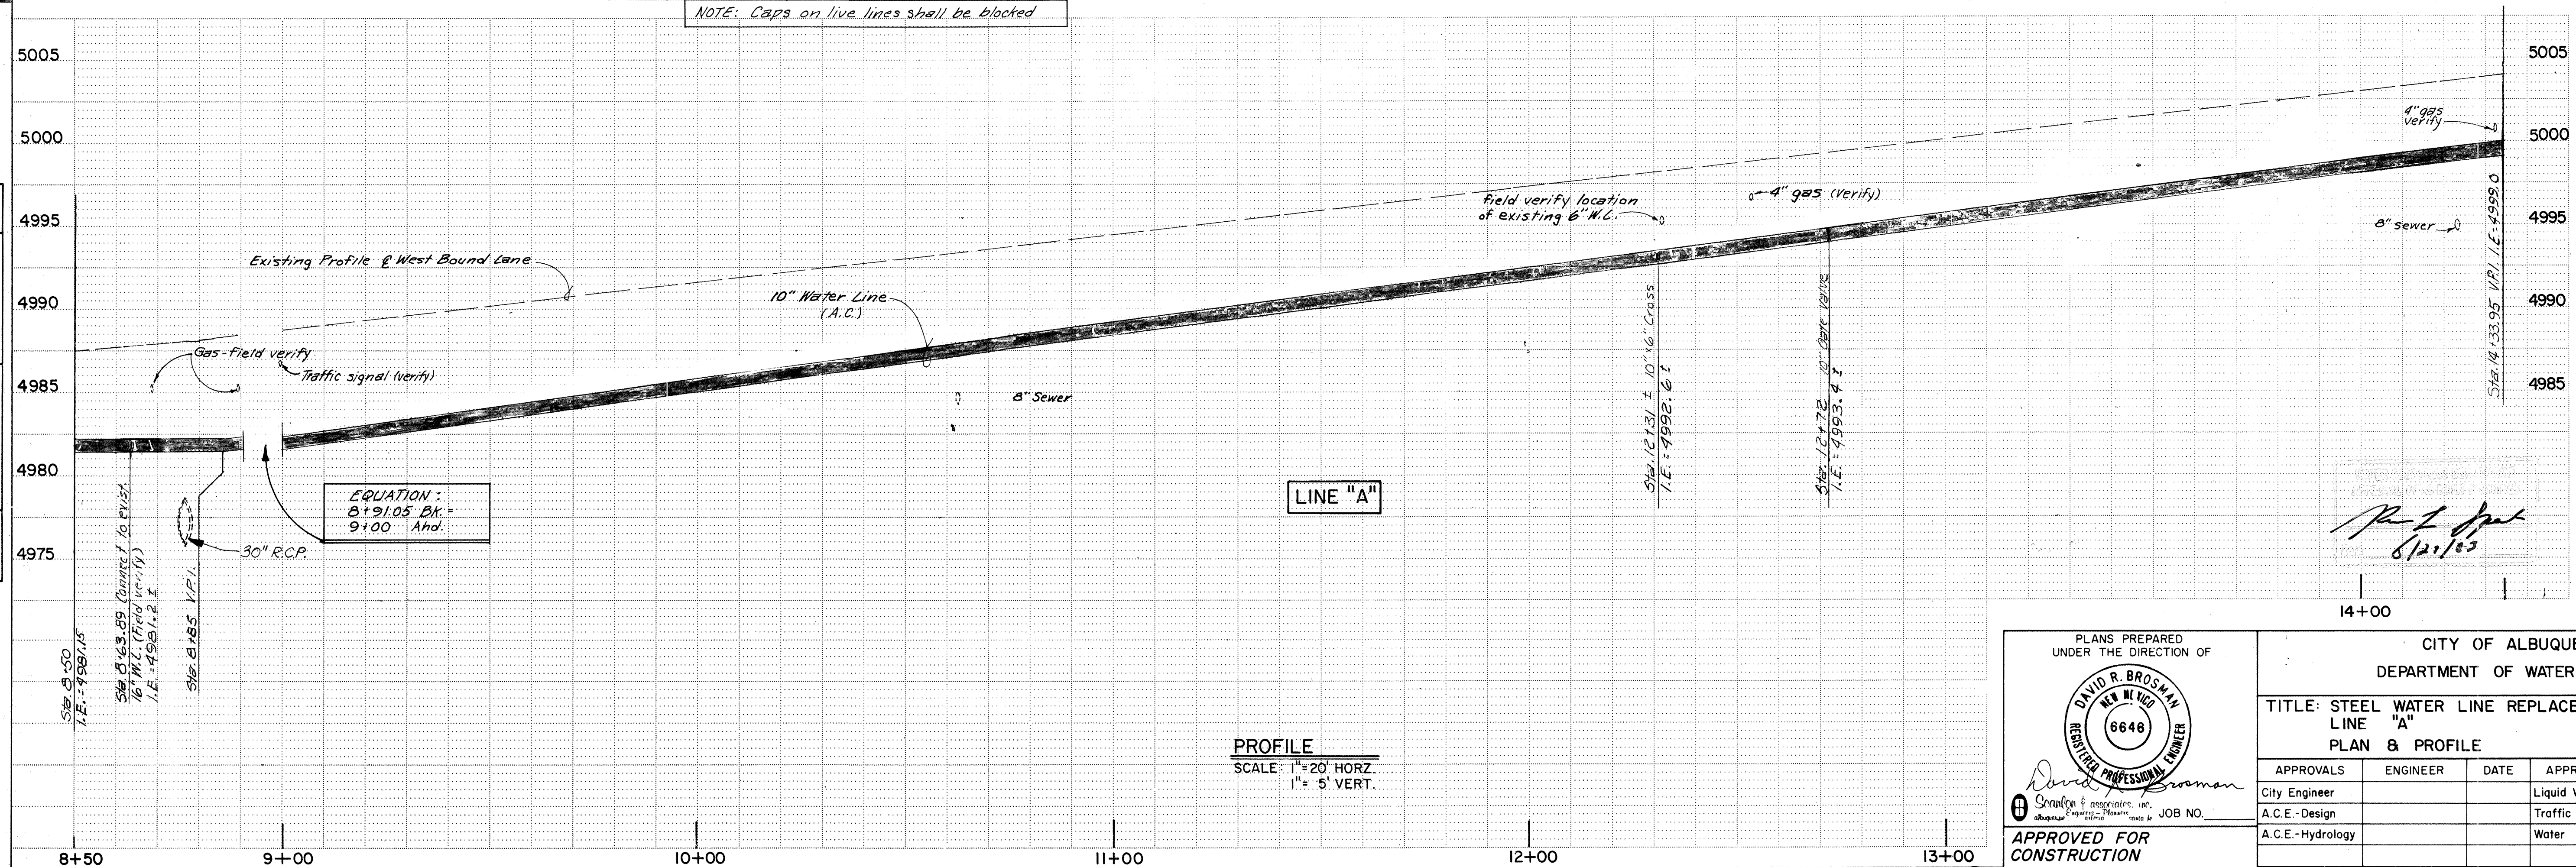


RECORD DRAWING

 PLANS PREPARED UNDER THE DIRECTION OF    JOB NO. _____	CITY OF ALBUQUERQUE DEPARTMENT OF WATER RESOURCES TITLE: STEEL WATER LINE REPLACEMENT - PHASE 1B LINE "A" PLAN & PROFILE <table border="1" style="width: 100%; border-collapse: collapse;"> <thead> <tr> <th style="width: 15%;">APPROVALS</th> <th style="width: 25%;">ENGINEER</th> <th style="width: 15%;">DATE</th> <th style="width: 15%;">APPROVALS</th> <th style="width: 20%;">ENGINEER</th> <th style="width: 10%;">DATE</th> </tr> </thead> <tbody> <tr> <td></td> <td>City Engineer</td> <td></td> <td></td> <td>Liquid Waste</td> <td></td> </tr> <tr> <td></td> <td>A.C.E.-Design</td> <td></td> <td></td> <td>Traffic</td> <td></td> </tr> <tr> <td></td> <td>A.C.E.-Hydrology</td> <td></td> <td></td> <td>Water</td> <td></td> </tr> </tbody> </table> DRAWING NO. _____ SHEET 43 OF 63 WR	APPROVALS	ENGINEER	DATE	APPROVALS	ENGINEER	DATE		City Engineer			Liquid Waste			A.C.E.-Design			Traffic			A.C.E.-Hydrology			Water	
APPROVALS	ENGINEER	DATE	APPROVALS	ENGINEER	DATE																				
	City Engineer			Liquid Waste																					
	A.C.E.-Design			Traffic																					
	A.C.E.-Hydrology			Water																					

SCANNED BY
MESA REPRO

DES CHECKED
NOTED
PICTURE NOTAT'NS CH'KD

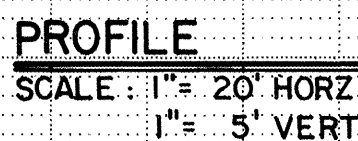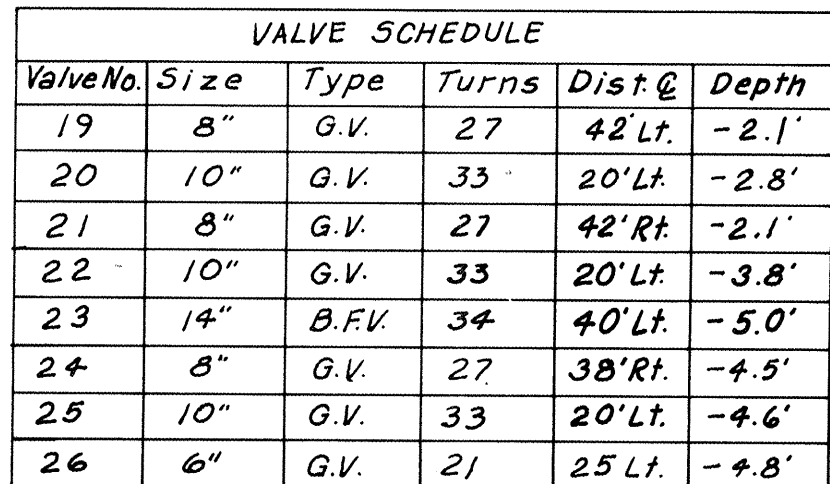


RECORD DRAWING

PLANS PREPARED UNDER THE DIRECTION OF  <i>David R. Brosman</i> David R. Brosman, Inc. Albuquerque, New Mexico JOB NO. _____	CITY OF ALBUQUERQUE DEPARTMENT OF WATER RESOURCES TITLE: STEEL WATER LINE REPLACEMENT — PHASE IB LINE "A" PLAN & PROFILE <table border="1" style="width: 100%; border-collapse: collapse;"> <thead> <tr> <th style="width: 25%;">APPROVALS</th> <th style="width: 25%;">ENGINEER</th> <th style="width: 10%;">DATE</th> <th style="width: 25%;">APPROVALS</th> <th style="width: 25%;">ENGINEER</th> <th style="width: 10%;">DATE</th> </tr> </thead> <tbody> <tr> <td>City Engineer</td> <td></td> <td></td> <td>Liquid Waste</td> <td></td> <td></td> </tr> <tr> <td>A.C.E.—Design</td> <td></td> <td></td> <td>Traffic</td> <td></td> <td></td> </tr> <tr> <td>A.C.E.—Hydrology</td> <td></td> <td></td> <td>Water</td> <td></td> <td></td> </tr> </tbody> </table> DRAWING NO. _____ SHEET 44 OF 63 WR	APPROVALS	ENGINEER	DATE	APPROVALS	ENGINEER	DATE	City Engineer			Liquid Waste			A.C.E.—Design			Traffic			A.C.E.—Hydrology			Water		
APPROVALS	ENGINEER	DATE	APPROVALS	ENGINEER	DATE																				
City Engineer			Liquid Waste																						
A.C.E.—Design			Traffic																						
A.C.E.—Hydrology			Water																						

PLAN	DATE
SURVEYED	
ALIGNED	
CHECKED	
BY	
NOTE BOOK	
NO.	

SCANNED BY
MESA REPRO

PROFILE	DATE
SURVEYED	
GRADES CHECKED	
BY	
NOTE BOOK	
NO.	

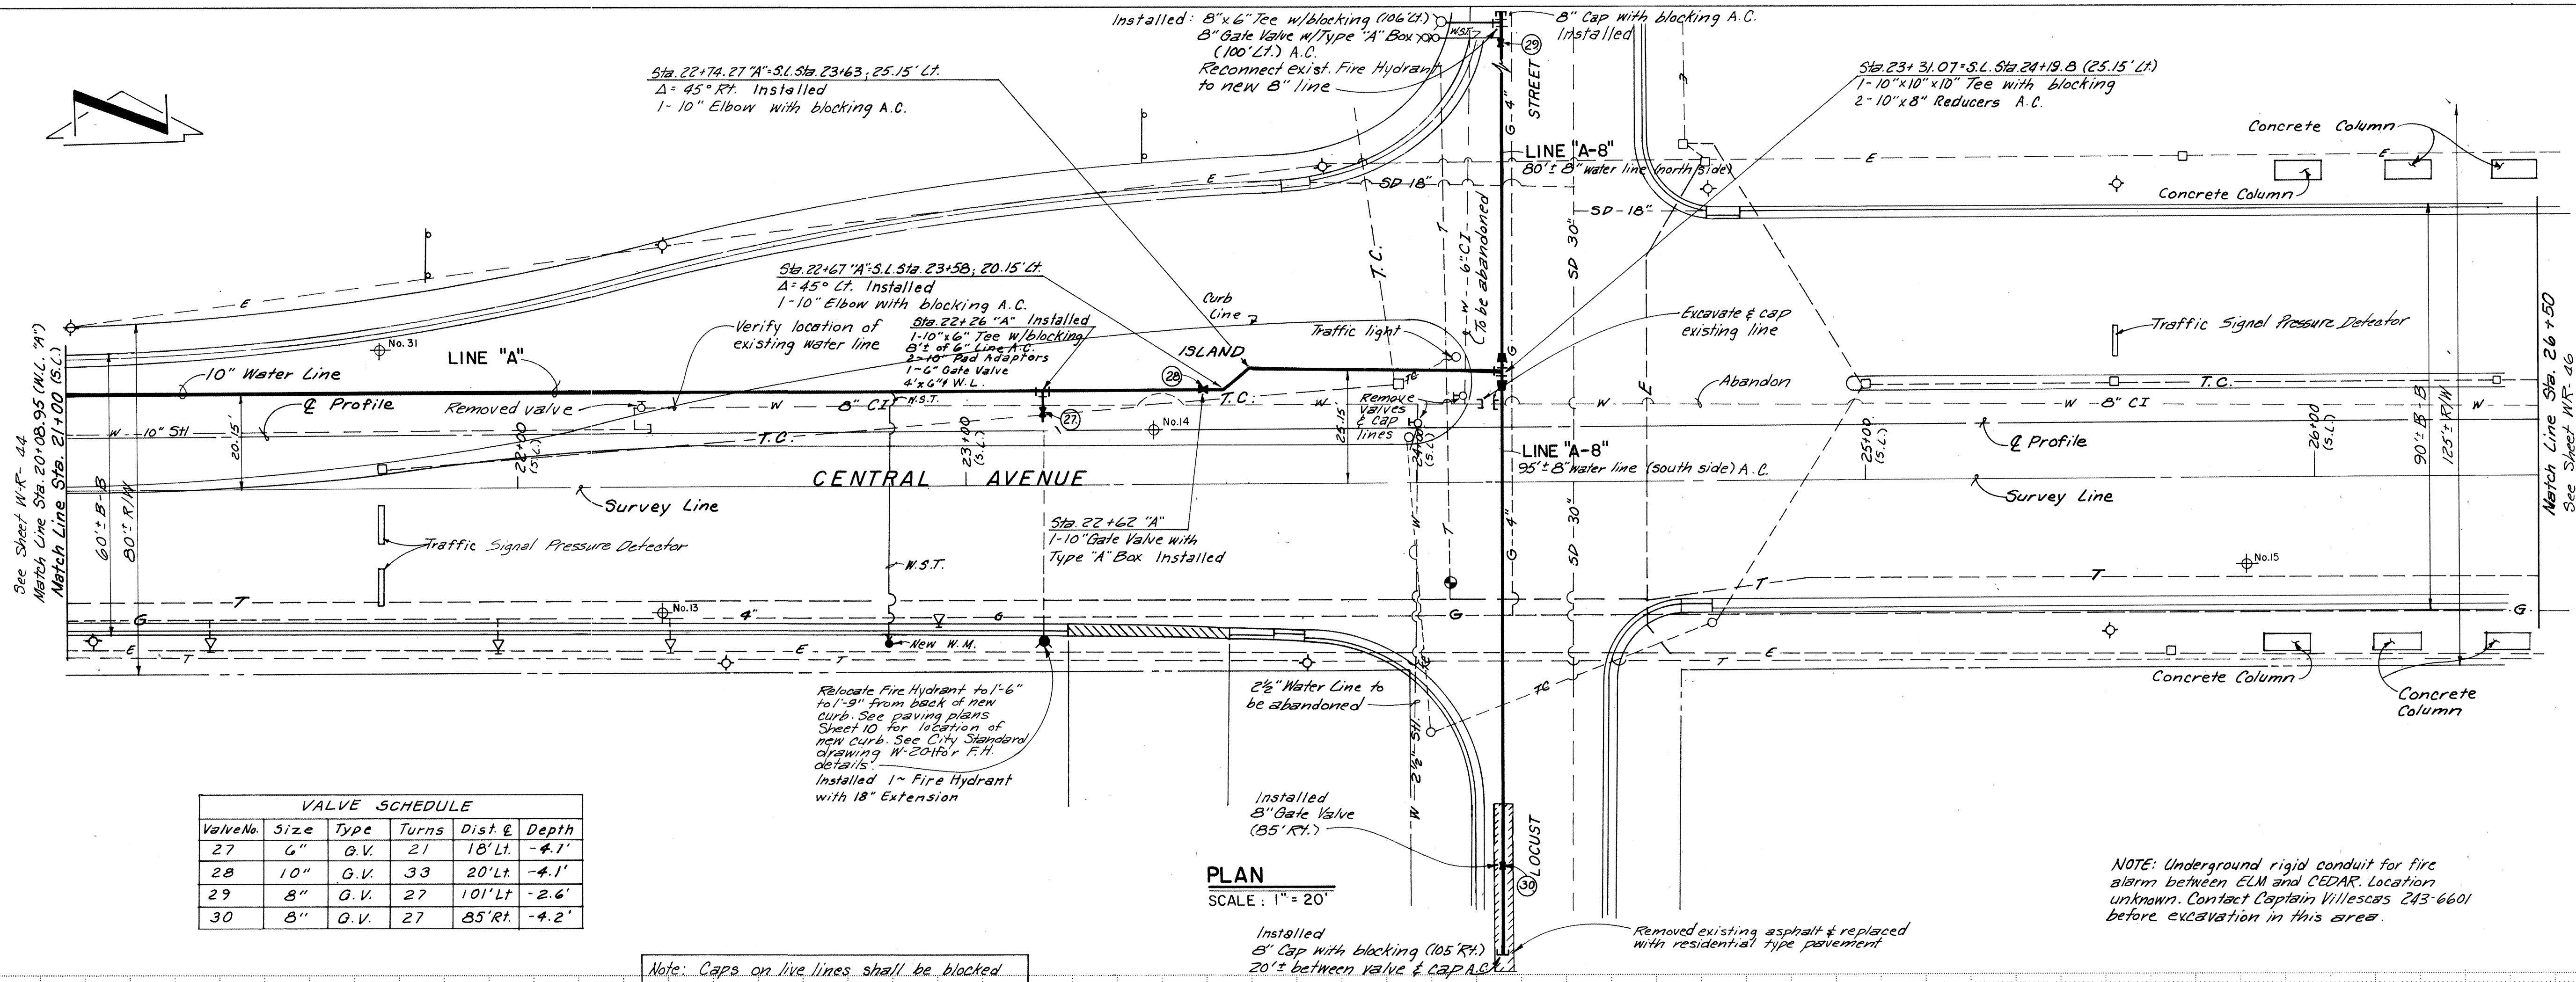


VALVE SCHEDULE					
Valve No.	Size	Type	Turns	Dist. &	Depth
27	6"	G.V.	21	18' Lt.	-4.1'
28	10"	G.V.	33	20' Lt.	-4.1'
29	8"	G.V.	27	101' Lt.	-2.6'
30	8"	G.V.	27	85' Rt.	-4.2'

PLAN
SCALE: 1" = 20'

NOTE: Underground rigid conduit for fire alarm between ELM and CEDAR. Location unknown. Contact Captain Villegas 243-6601 before excavation in this area.

Note: Caps on live lines shall be blocked.

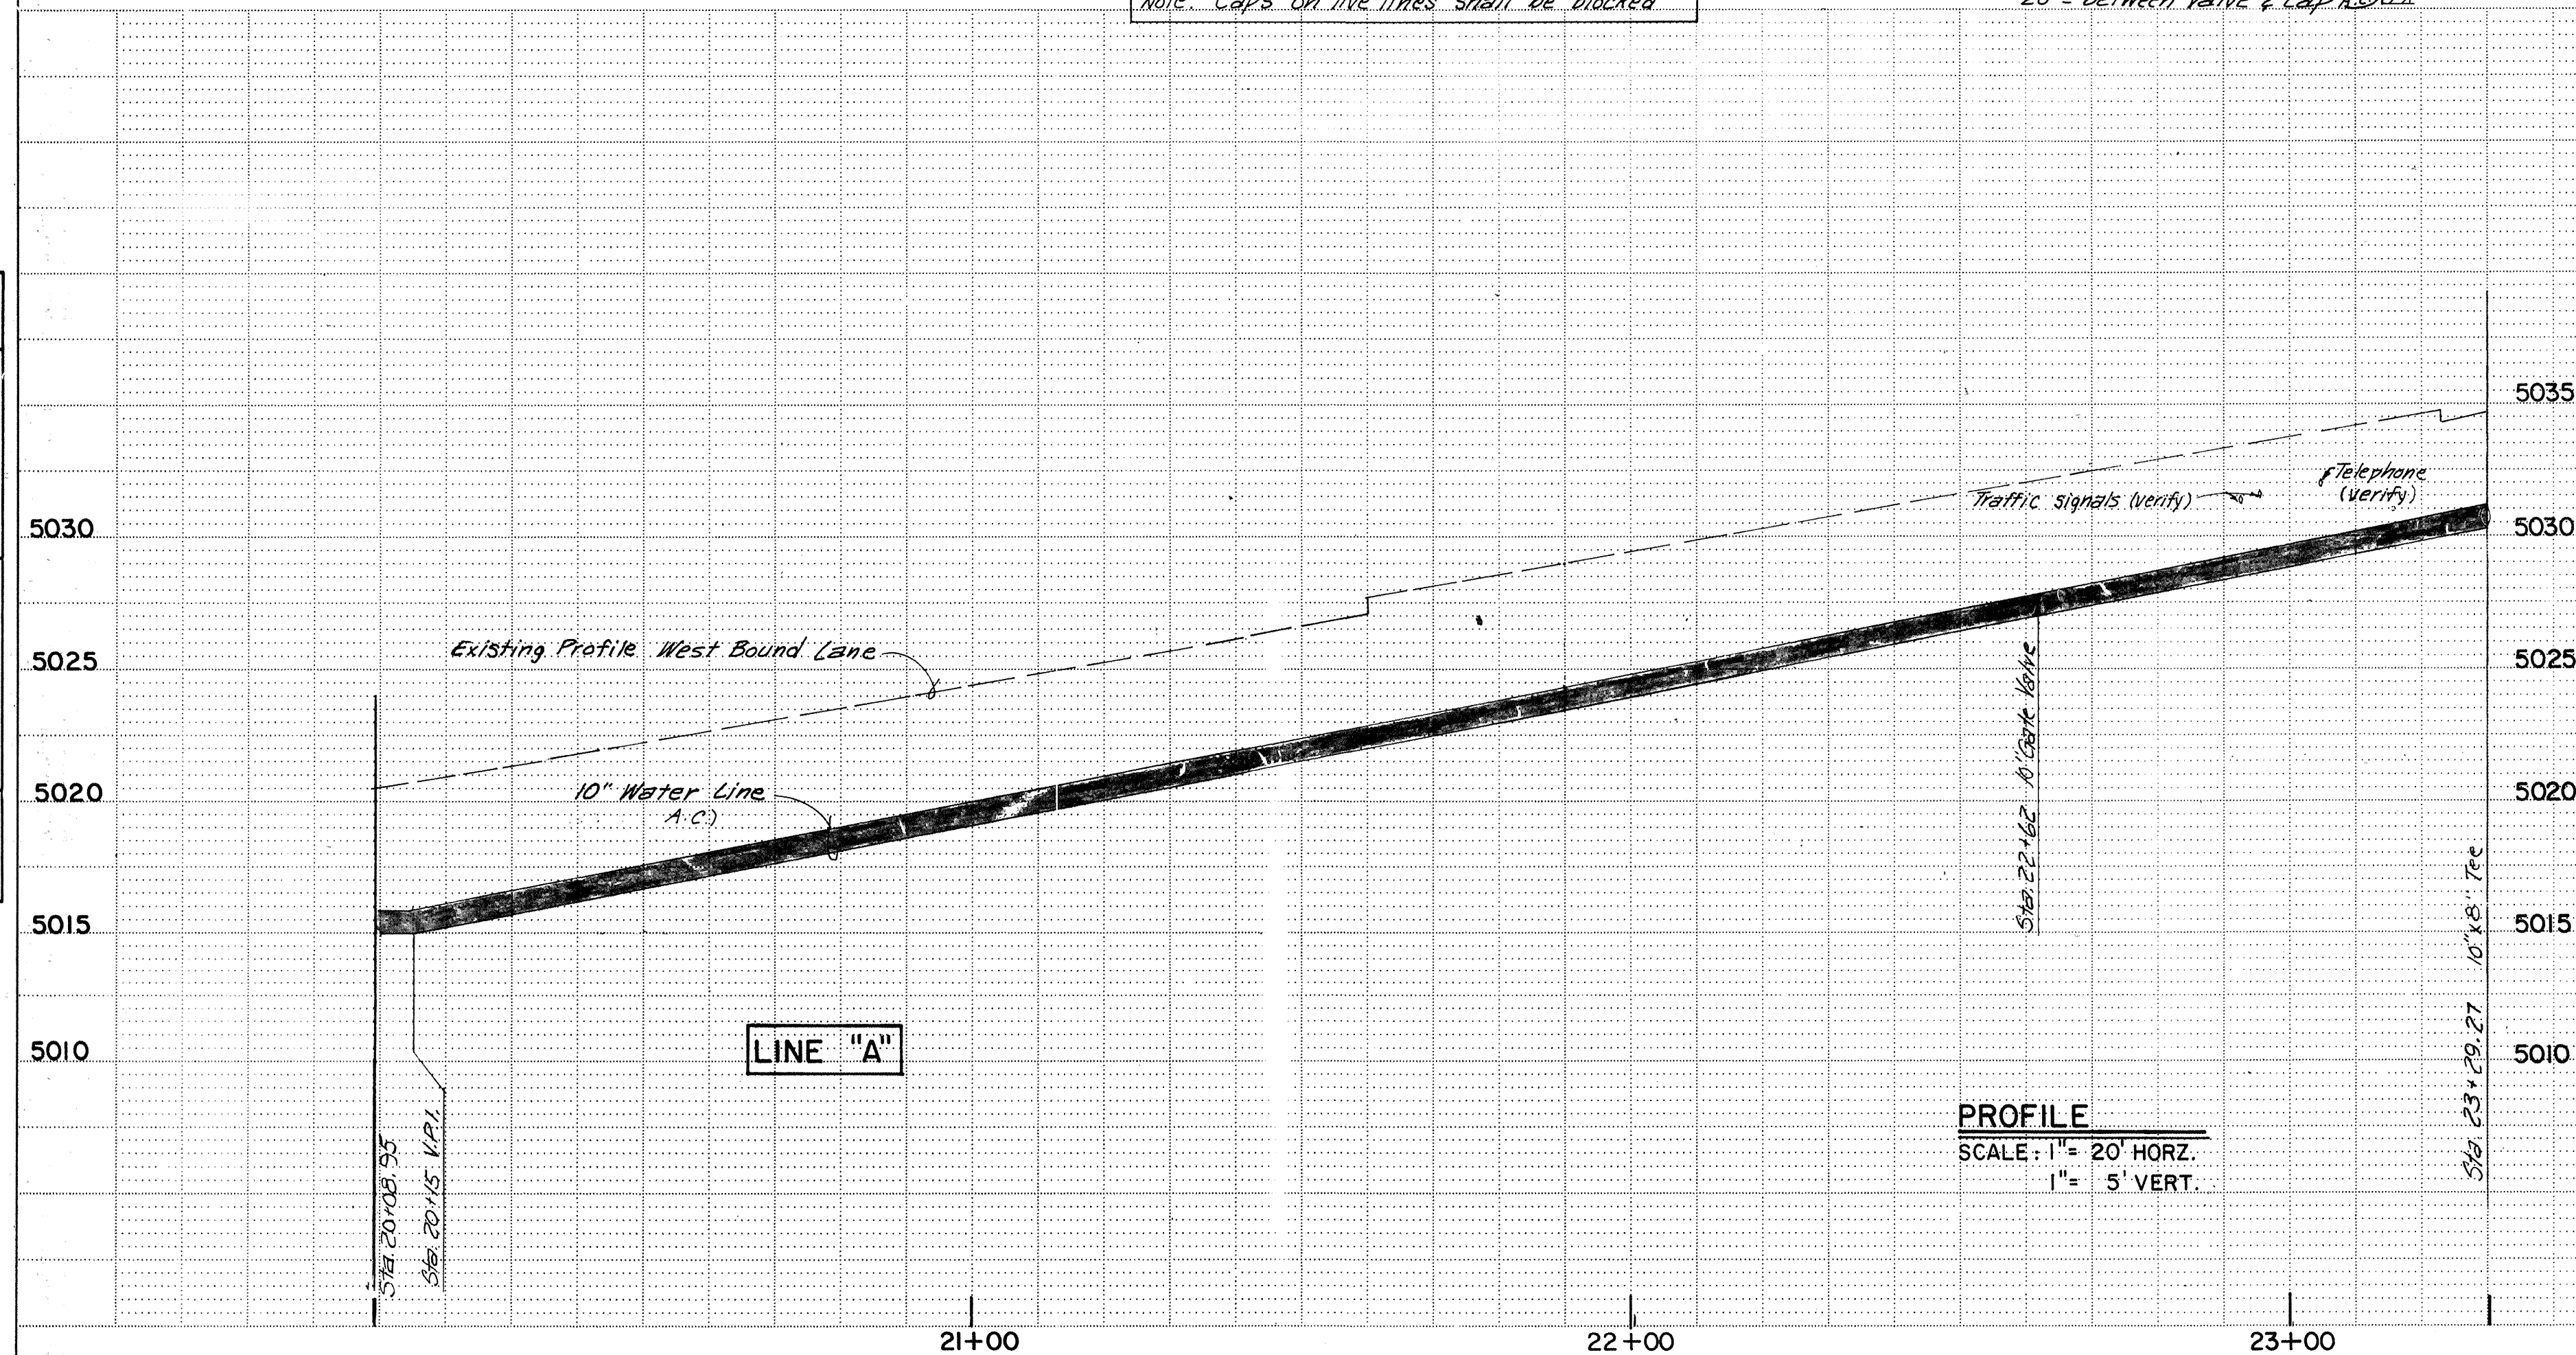

PROFILE
SCALE: 1" = 20' HORIZ.
1" = 5' VERT.

RECORD DRAWING

PLANS PREPARED
UNDER THE DIRECTION OF
DAVID P. BROWN
REGISTERED PROFESSIONAL ENGINEER
6648

APPROVED FOR
CONSTRUCTION

CITY ENGINEER DATE

CITY OF ALBUQUERQUE
DEPARTMENT OF WATER RESOURCES

TITLE: STEEL WATER LINE REPLACEMENT - PHASE 1B
LINE "A"
PLAN & PROFILE

APPROVALS	ENGINEER	DATE	APPROVALS	ENGINEER	DATE
City Engineer			Liquid Waste		
A.C.E.-Design			Traffic		
A.C.E.-Hydrology			Water		



DRAWING NO. SHEET 45 OF 63
WR

SURVEY INFORMATION		BENCH MARKS		AS BUILT INFORMATION	
MAP NO.	K-15-2	CONTRACTOR	New Concepts	WORK	CONTRACTOR
EST. NO.		DATE	1/1/79	STATION	DATE
		BY	Scanlon & Associates	ACCEPTANCE	DATE
		REMARKS		REVISIONS	DATE
		DESIGNED BY	D.R.B.	DESIGNED BY	DATE
		DRAWN BY	W.L.L.	DRAWN BY	DATE
		CHECKED BY	D.R.B.	CHECKED BY	DATE

PLAN	DATE	BY
NO.		
NOTE BOOK		
NO.		

SCANNED BY
MESA REPRO

PROFILE	DATE	BY
NO.		
NOTE BOOK		
NO.		

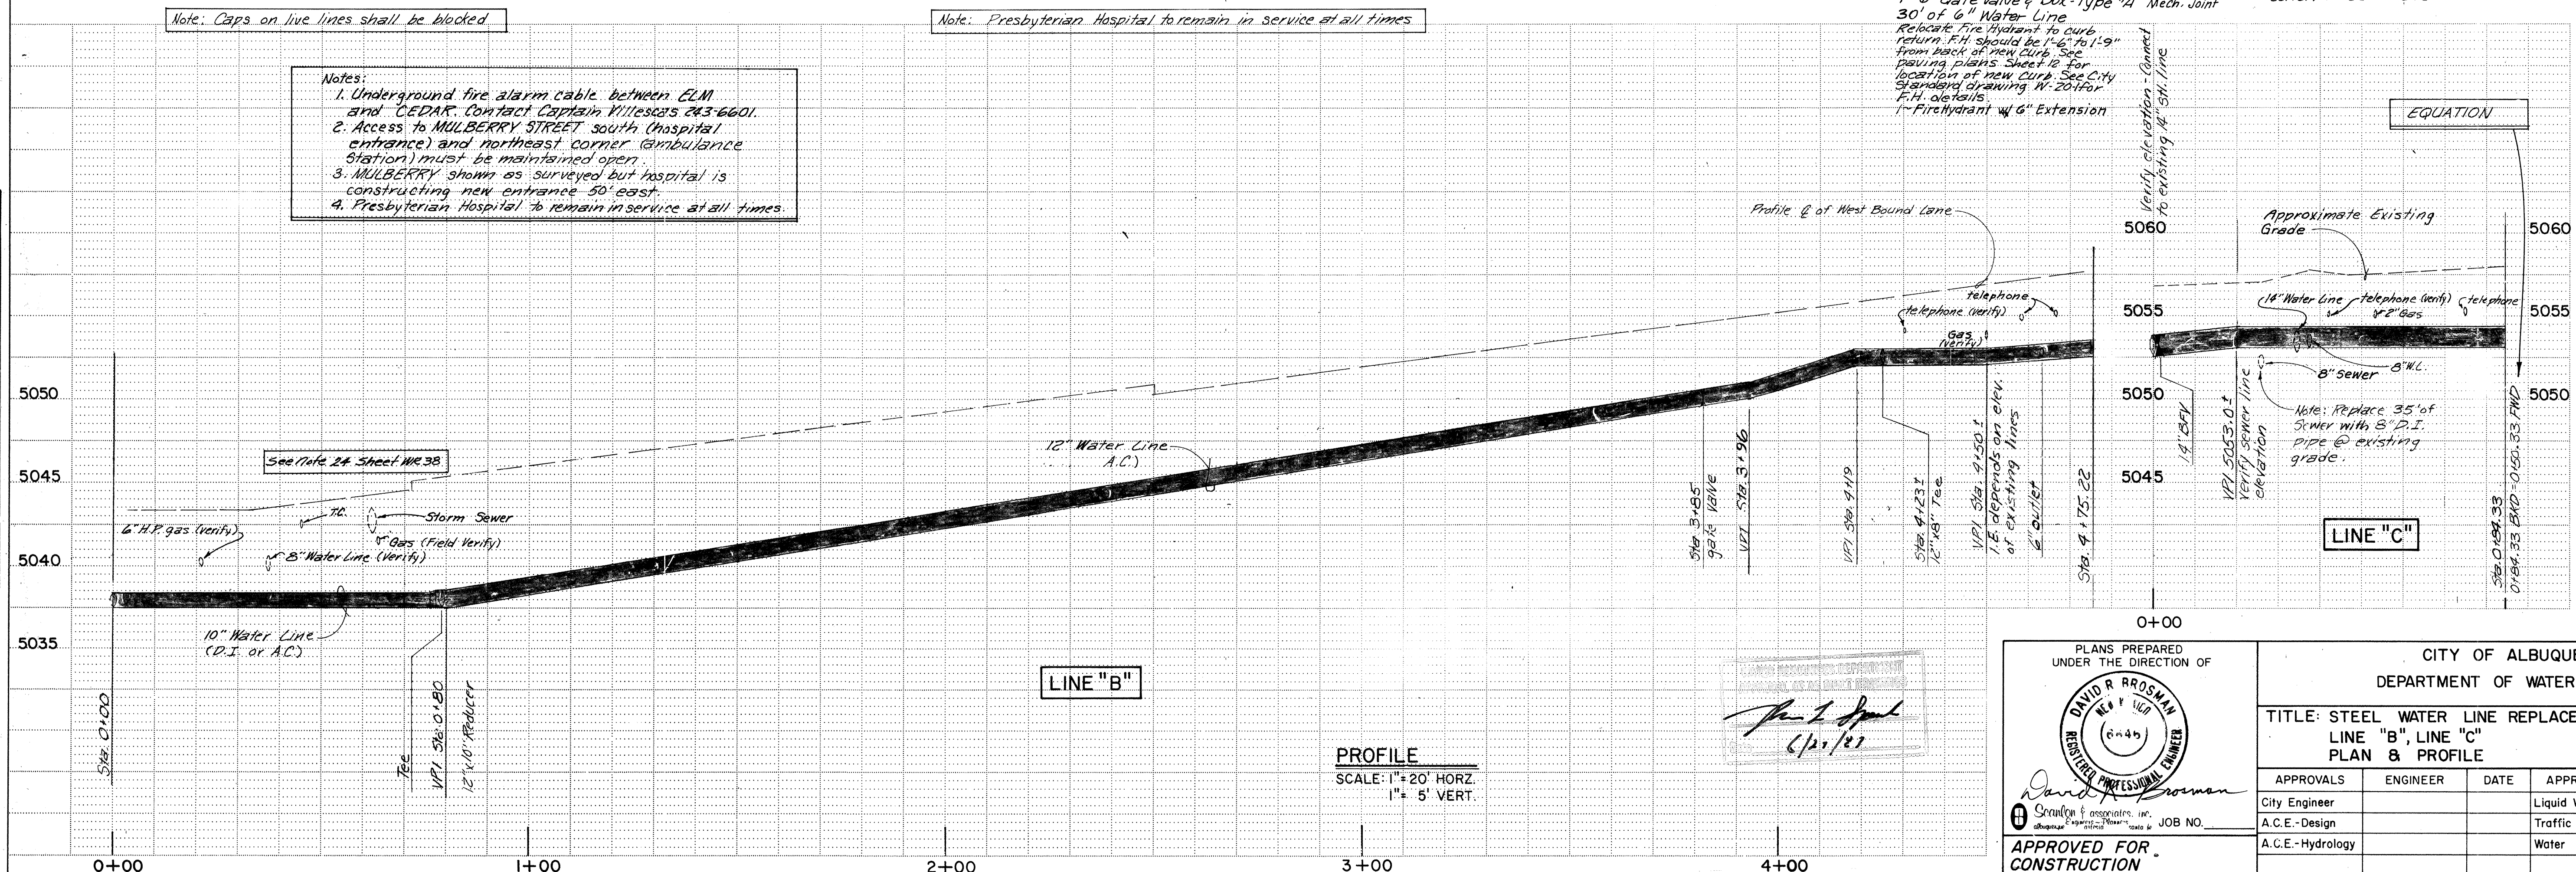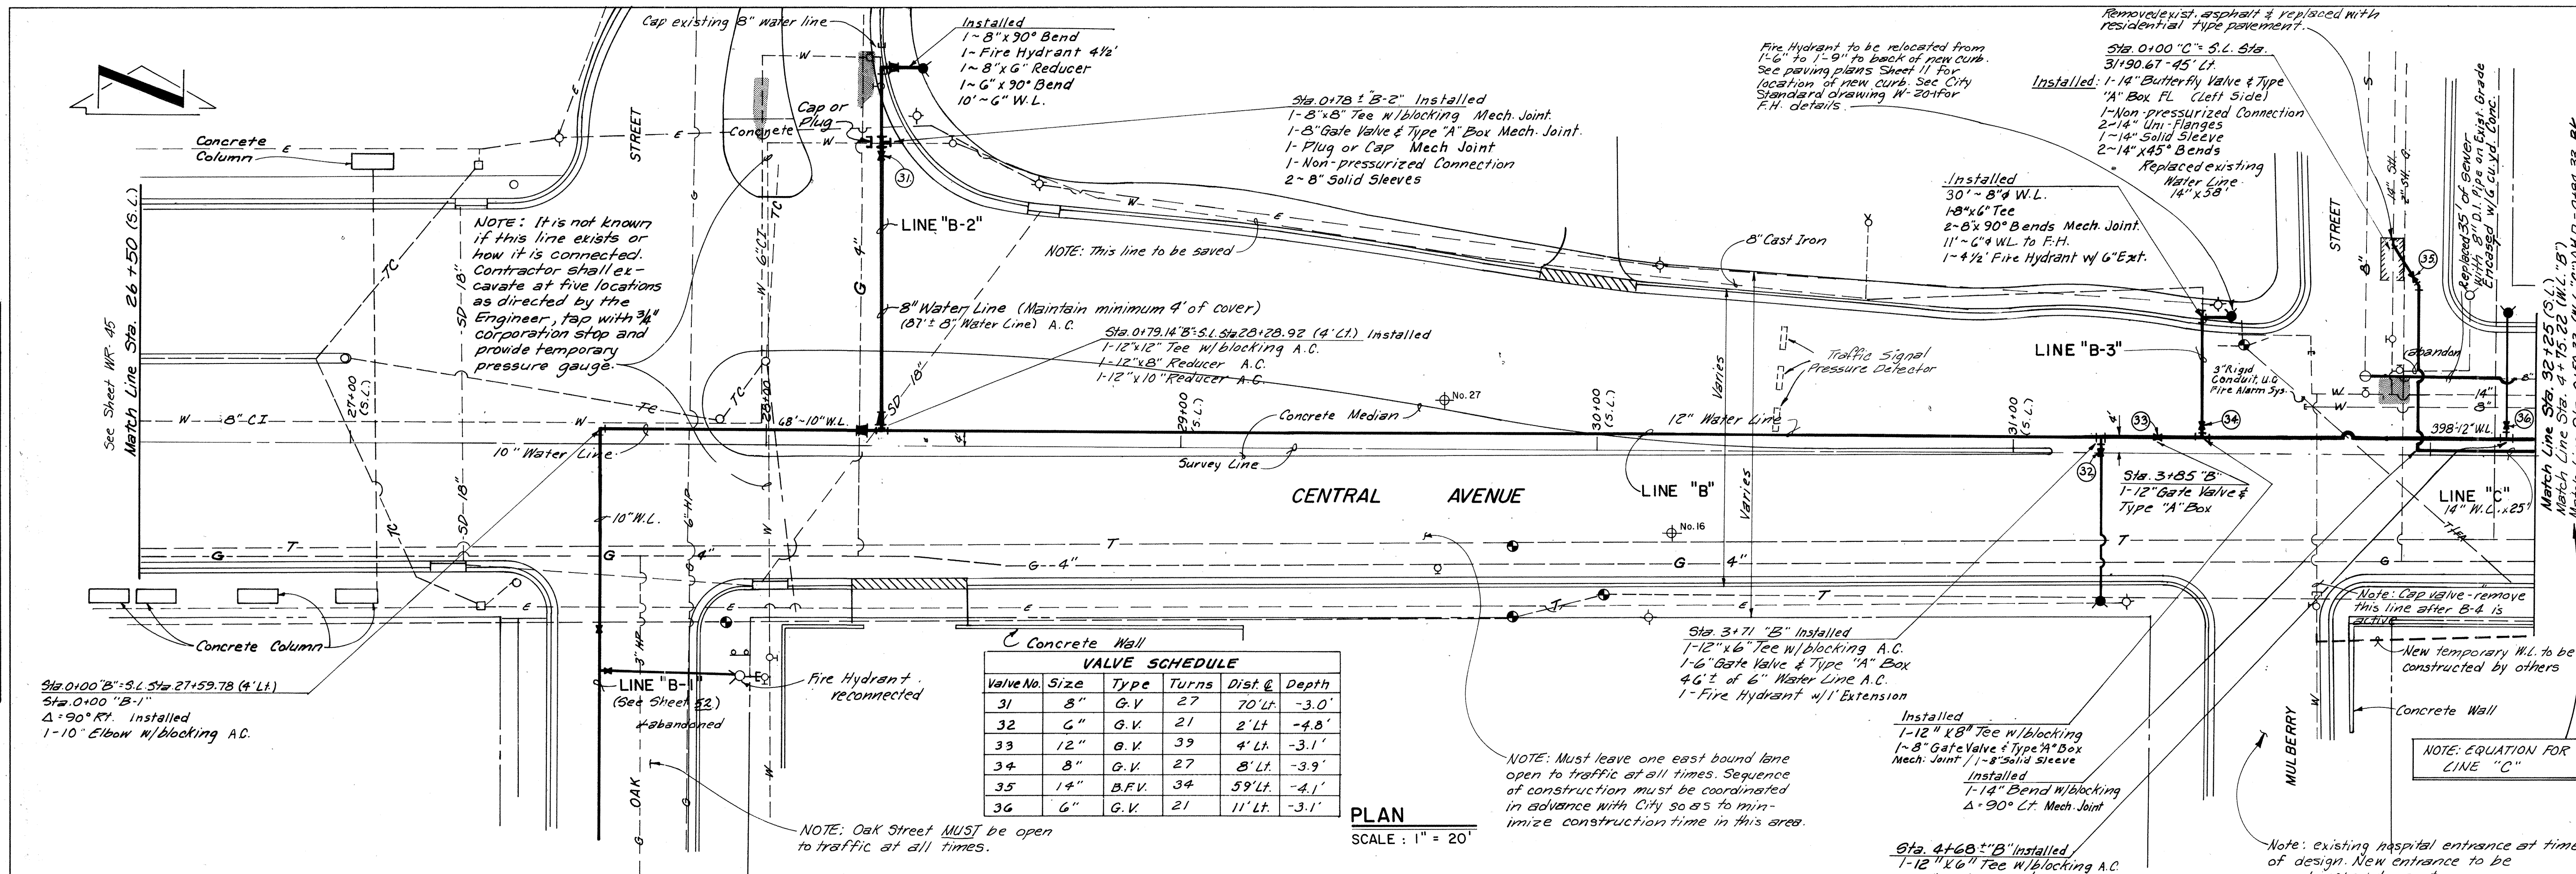


RECORD DRAWING

PLANS PREPARED UNDER THE DIRECTION OF DAVID R. ROSSMAN REGISTERED PROFESSIONAL ENGINEER No. 6440		CITY OF ALBUQUERQUE DEPARTMENT OF WATER RESOURCES	
TITLE: STEEL WATER LINE REPLACEMENT - PHASE 1B LINE "B", LINE "C" PLAN & PROFILE			
APPROVALS	ENGINEER	DATE	APPROVALS
City Engineer			Liquid Waste
A.C.E.-Design			Traffic
A.C.E.-Hydrology			Water
DRAWING NO.		SHEET 46 OF 63 WR	

PLAN	DATE	BY	DATE
SURVEYED			
NOTES			
ALIGNED			
CHECKED			
RT OF WAY			
CHECKED			

SCANNED BY:
MESA REPRO

PROFILE	DATE	BY	DATE
SURVEYED			
NOTES			
ALIGNED			
CHECKED			
STRUCTURE			
NOTATIONS			
CHECKED			

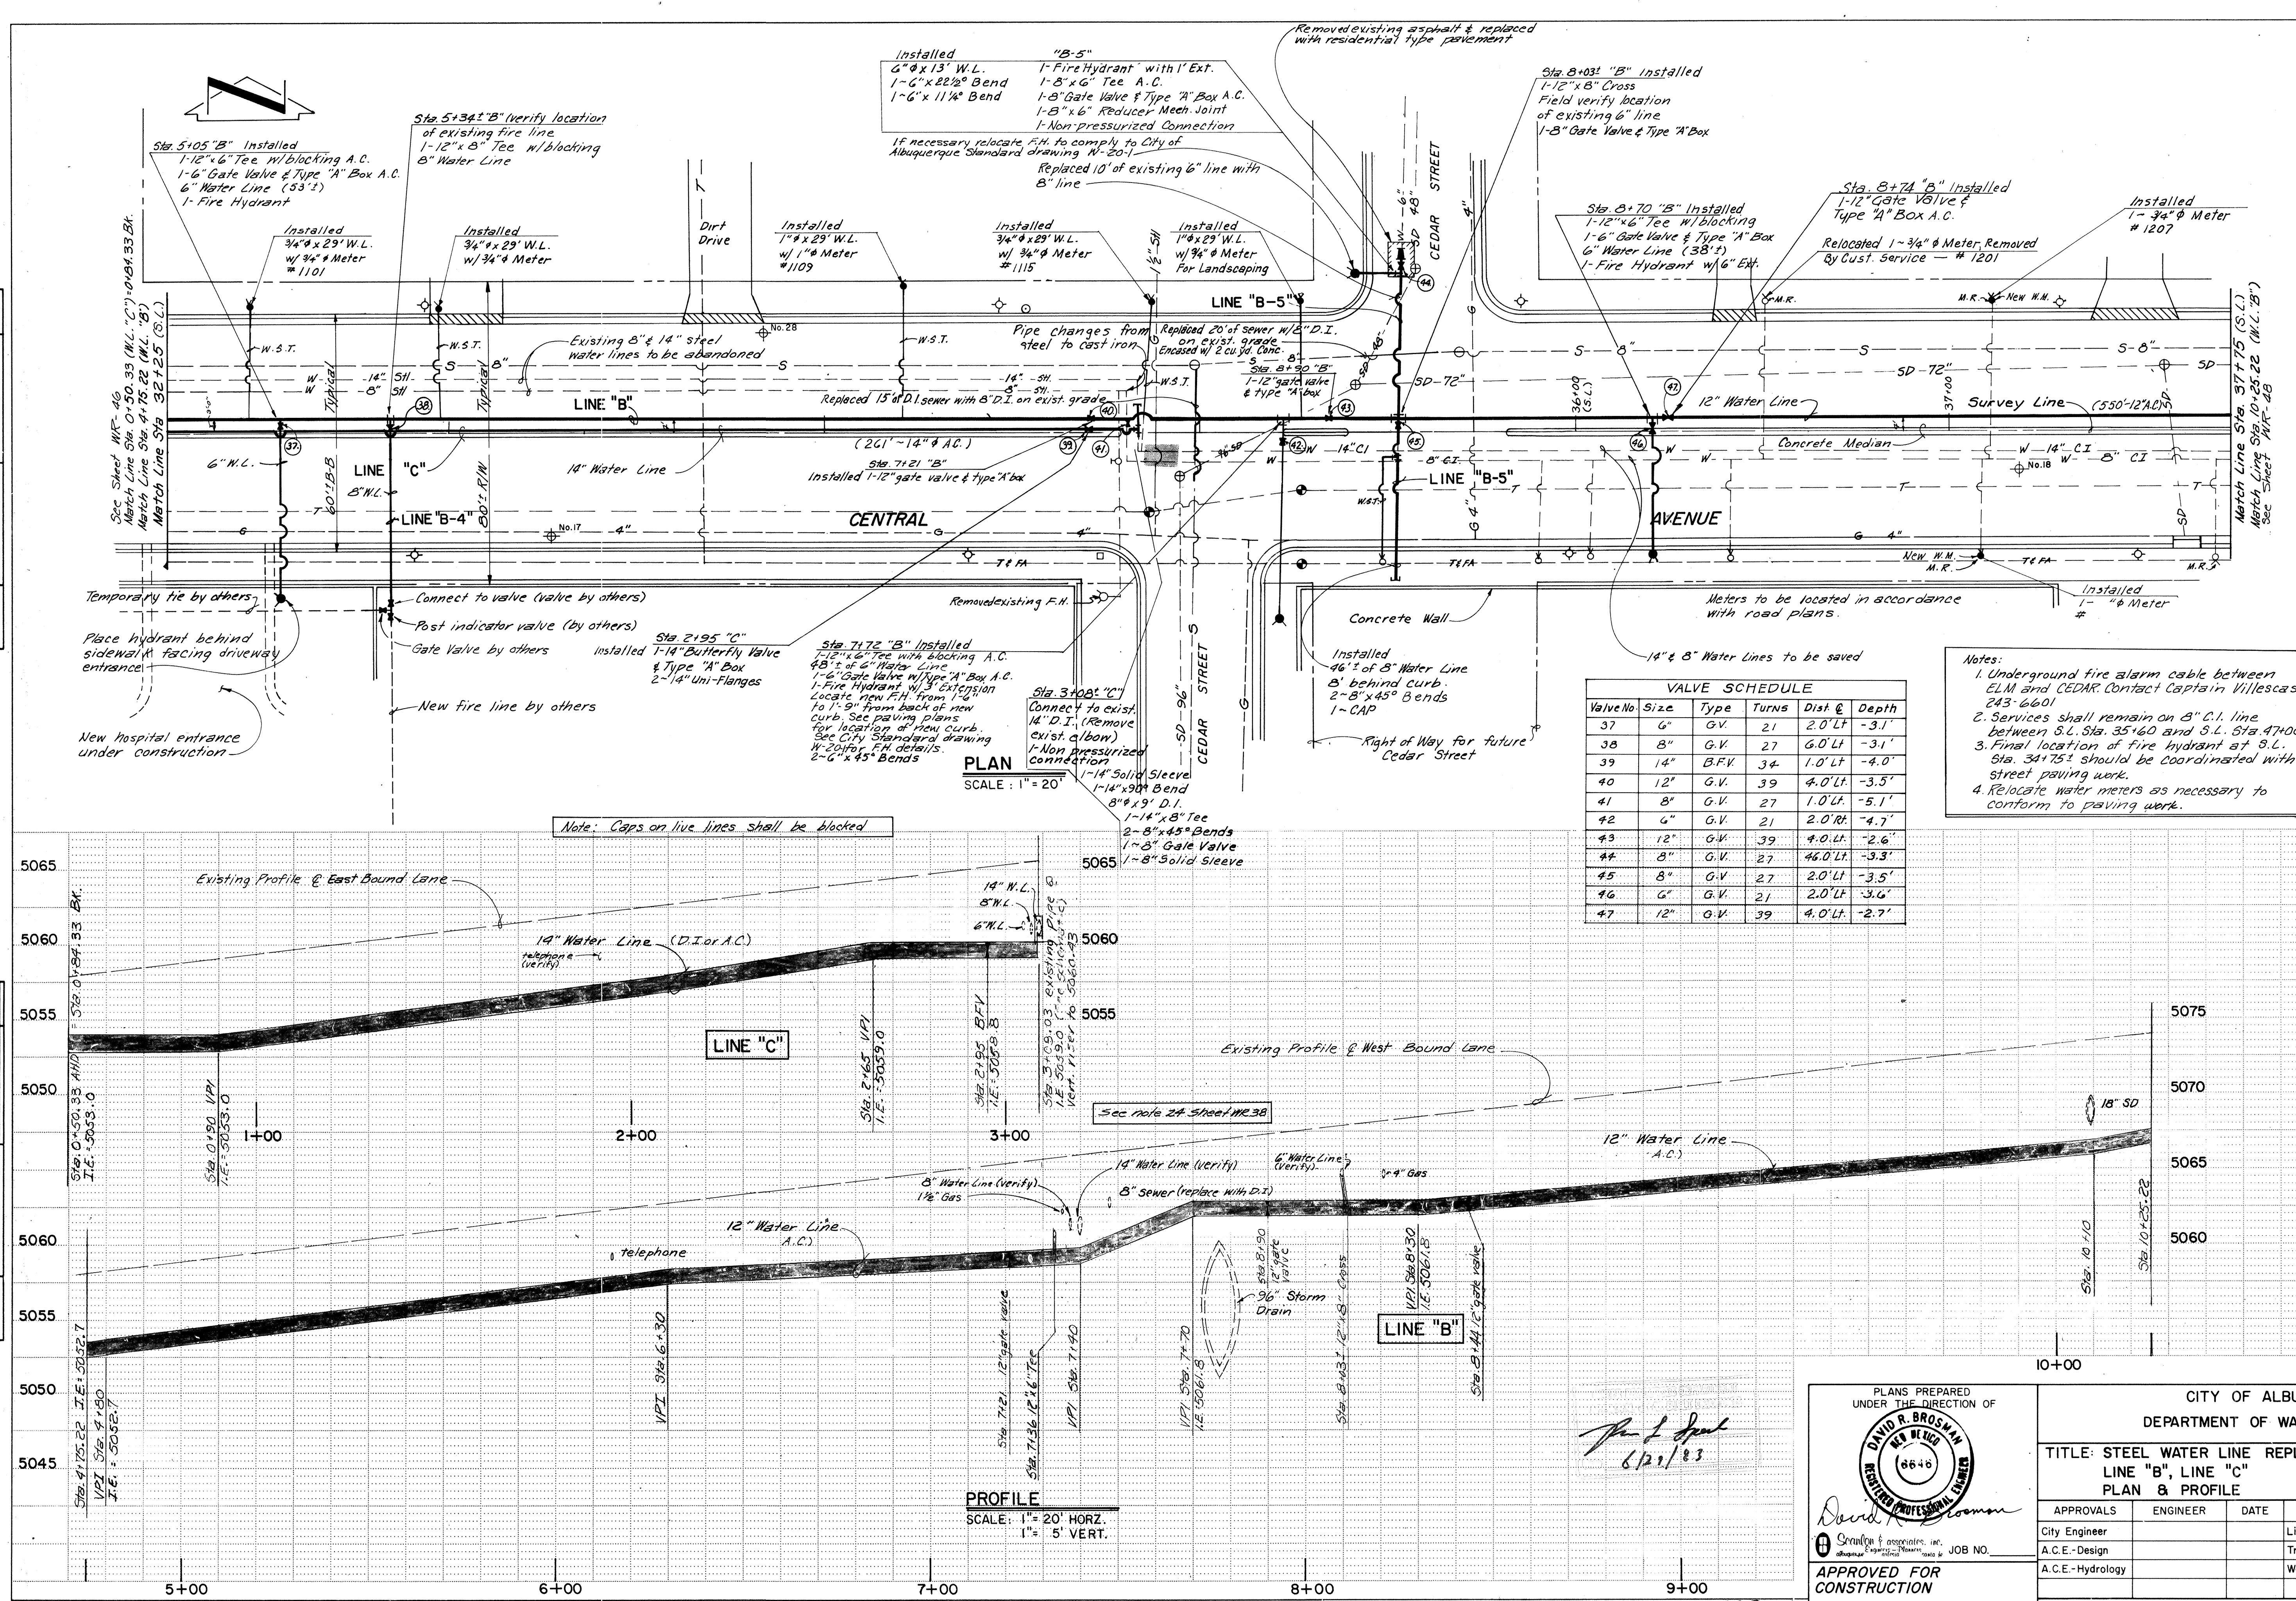

RECORD DRAWING

PLANS PREPARED UNDER THE DIRECTION OF
DAVID R. BROSMAN
REGISTERED PROFESSIONAL ENGINEER
NO. 6640

APPROVED FOR CONSTRUCTION
CITY ENGINEER
DATE

CITY OF ALBUQUERQUE
DEPARTMENT OF WATER RESOURCES

TITLE: STEEL WATER LINE REPLACEMENT - PHASE 1B
LINE "B", LINE "C"
PLAN & PROFILE

APPROVALS	ENGINEER	DATE	APPROVALS	ENGINEER	DATE
City Engineer			Liquid Waste		
A.C.E.-Design			Traffic		
A.C.E.-Hydrology			Water		


DRAWING NO. 47 OF 63
SHEET WR

SURVEY INFORMATION		BENCH MARKS		AS BUILT INFORMATION	
MAP NO. 4-15-2	FIELD NOTES	5-K/15A 2" Brass Tablet set in sidewalk	CONTRACTOR	DATE	DATE
EST. NO.	NO.	31.1' North & Central, 104.4' West & Cedar	STANDARD BY	DATE	DATE
	NO.	Scanlon Associates 11/79	CONTRACTOR	DATE	DATE
	NO.	Scanlon Associates 11/79	STANDARD BY	DATE	DATE
	NO.	Scanlon Associates 11/79	CONTRACTOR	DATE	DATE
	NO.	Scanlon Associates 11/79	STANDARD BY	DATE	DATE
	NO.	Scanlon Associates 11/79	CONTRACTOR	DATE	DATE
	NO.	Scanlon Associates 11/79	STANDARD BY	DATE	DATE
	NO.	Scanlon Associates 11/79	CONTRACTOR	DATE	DATE
	NO.	Scanlon Associates 11/79	STANDARD BY	DATE	DATE


PLAN	DATE	BY
SURVEYED		
NOTED		
PLANNED		
NOTED		
PLANNED		

SCANNED BY
MESA REPRO

PROFILE	DATE	BY
SURVEYED		
NOTED		
PLANNED		
NOTED		
PLANNED		

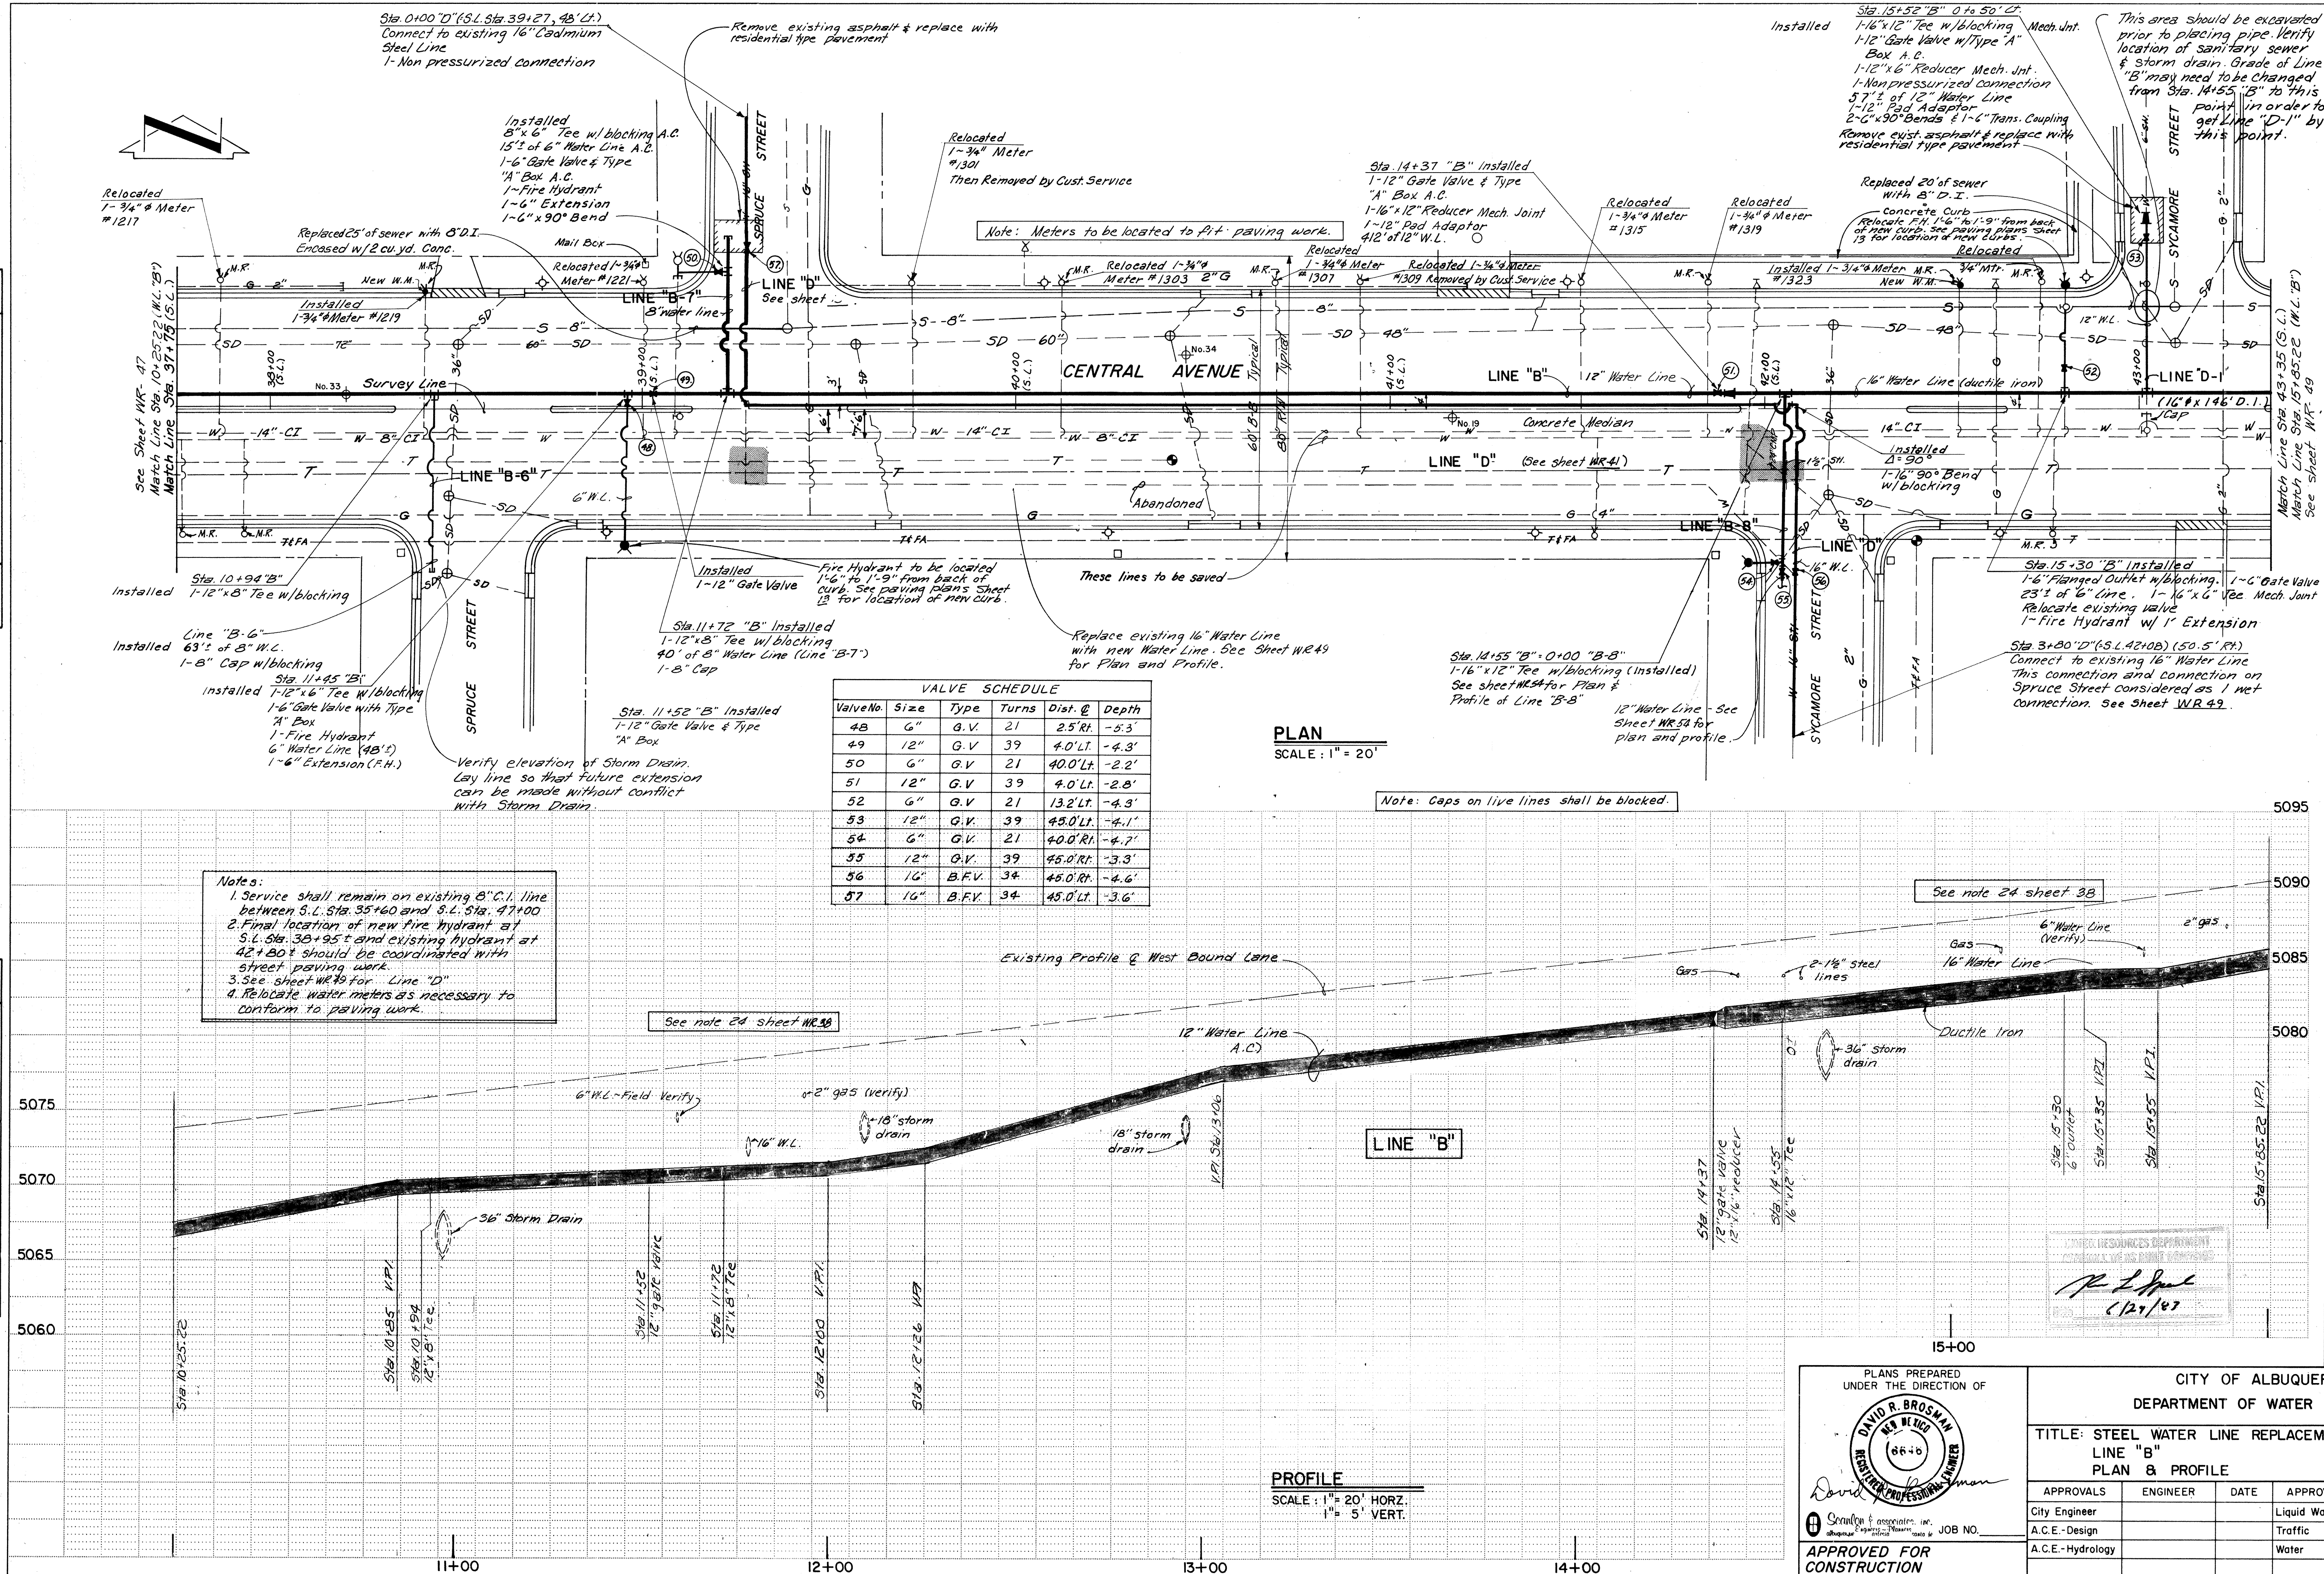

RECORD DRAWING

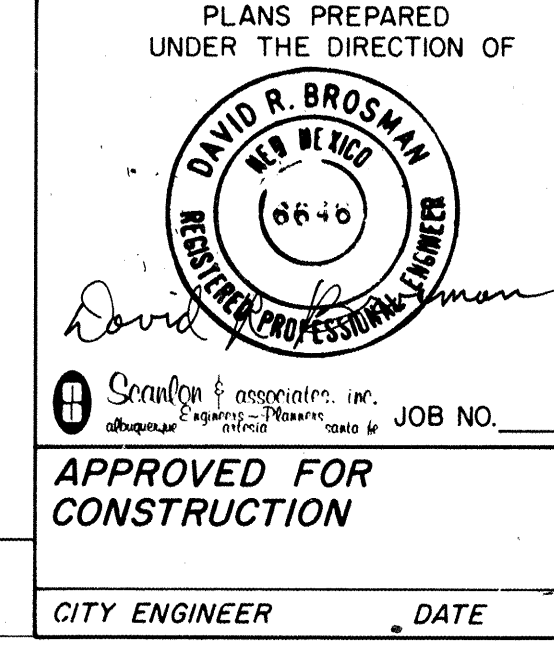


CITY OF ALBUQUERQUE DEPARTMENT OF WATER RESOURCES					
TITLE: STEEL WATER LINE REPLACEMENT - PHASE 1B LINE "B" PLAN & PROFILE					
APPROVALS	ENGINEER	DATE	APPROVALS	ENGINEER	DATE
City Engineer			Liquid Waste		
A.C.E.-Design			Traffic		
A.C.E.-Hydrology			Water		
DRAWING NO.			SHEET 48 OF 63 WR		

PLAN	DATE	BY	CHECKED
SURVEYED PLOTTED NOTED BY			
NOTE BOOK NO.			

SCANNED BY
MESA REPRO


PROFILE	DATE	BY	CHECKED
SURVEYED PLOTTED NOTED BY			
NOTE BOOK NO.			

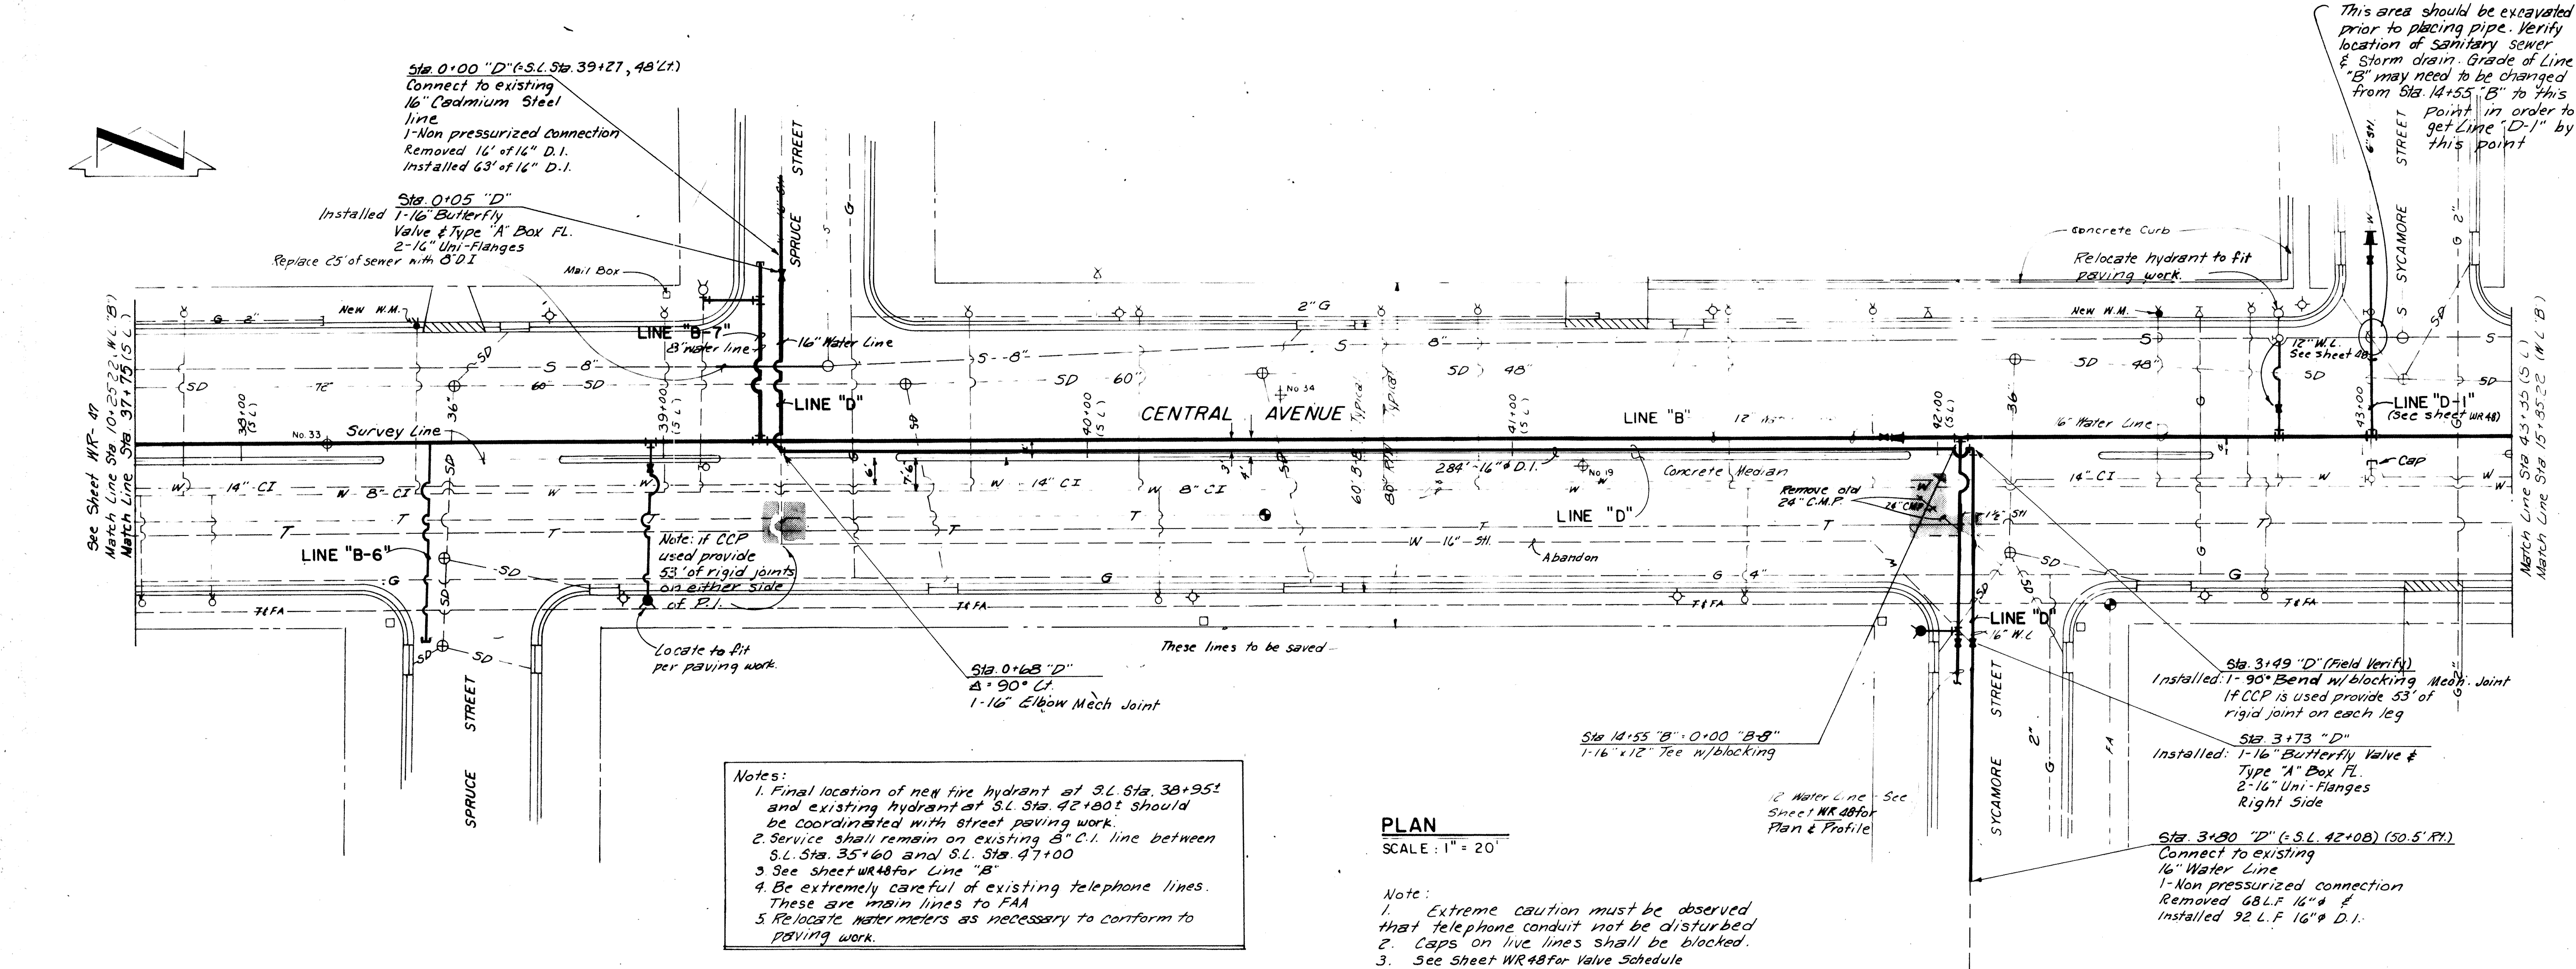

- Notes:
1. Final location of new fire hydrant at S.L. Sta. 38+95' and existing hydrant at S.L. Sta. 42+00' should be coordinated with street paving work.
 2. Service shall remain on existing 8\" C.I. line between S.L. Sta. 35+60 and S.L. Sta. 47+00
 3. See sheet WR48 for Line "B"
 4. Be extremely careful of existing telephone lines. These are main lines to FAA
 5. Relocate water meters as necessary to conform to paving work.

PLAN
SCALE: 1" = 20'

- Note:
1. Extreme caution must be observed that telephone conduit not be disturbed.
 2. Caps on live lines shall be blocked.
 3. See Sheet WR48 for Valve Schedule

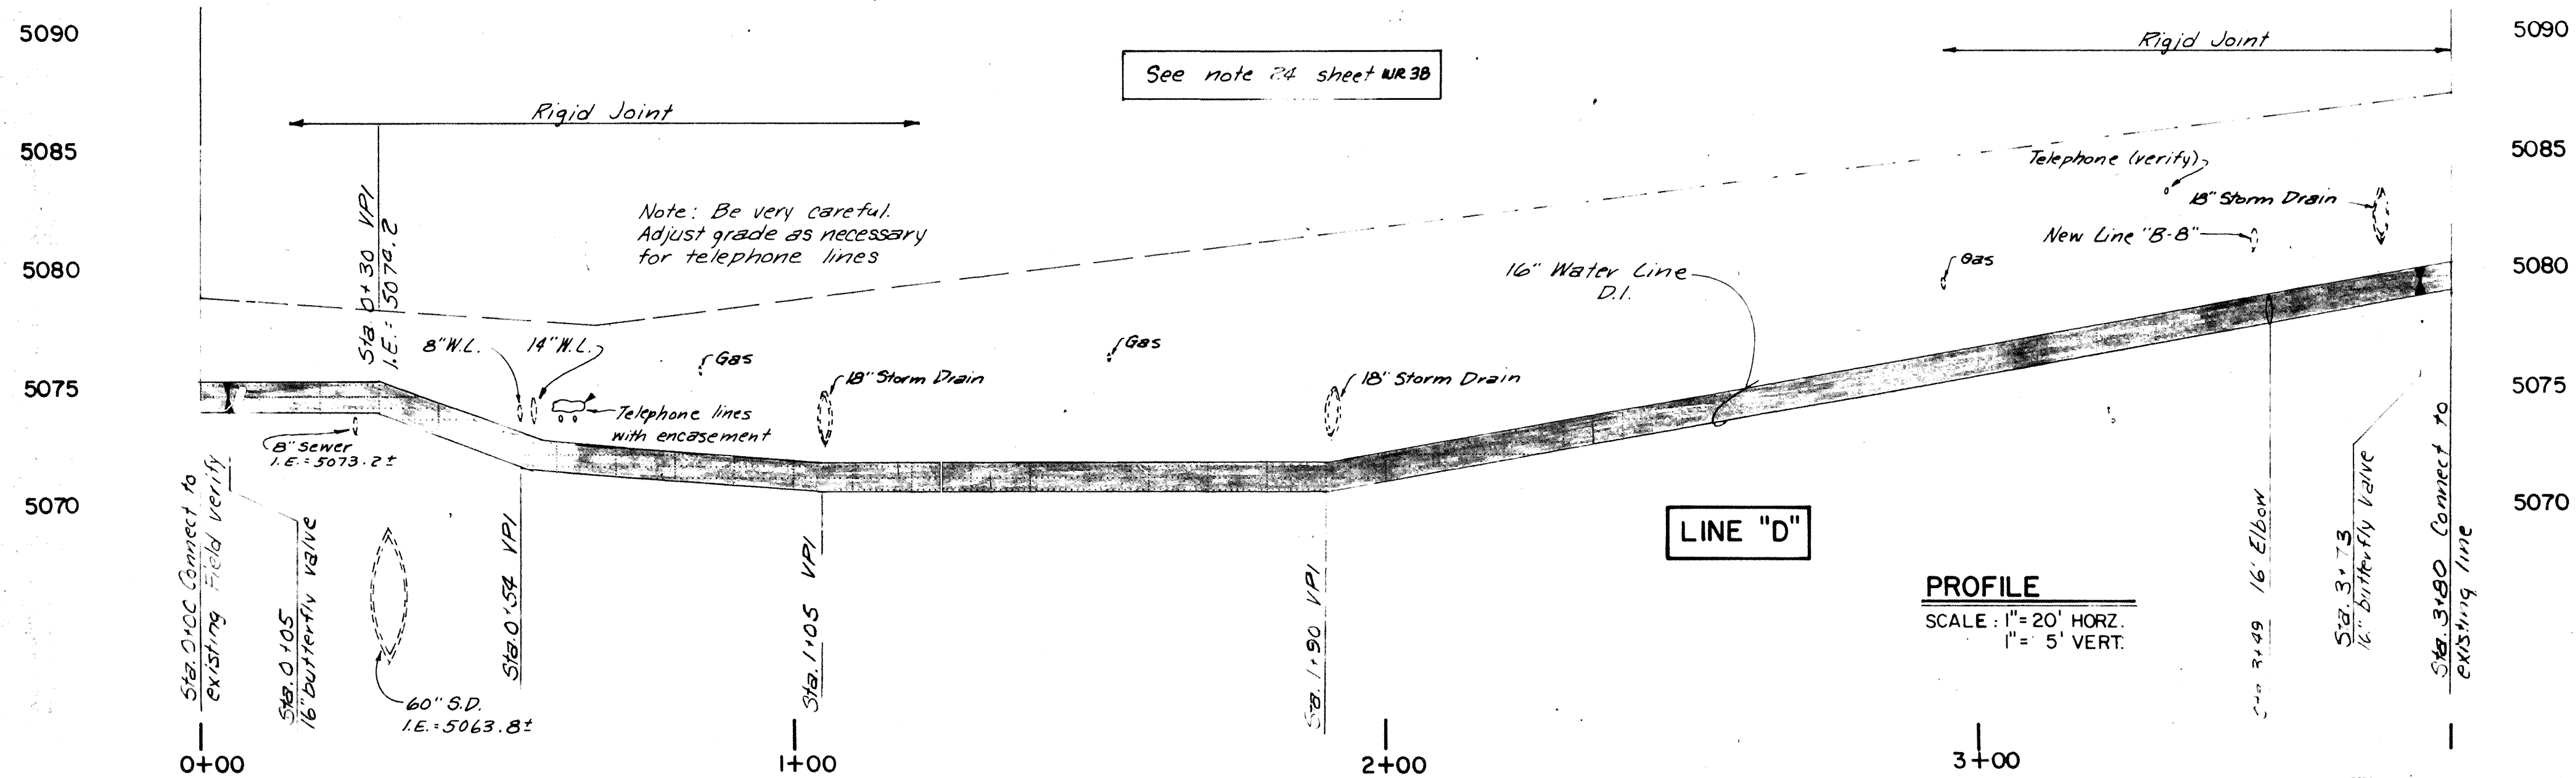


PROFILE
SCALE: 1" = 20' HORZ.
1" = 5' VERT.


RECORD DRAWING


		CITY OF ALBUQUERQUE DEPARTMENT OF WATER RESOURCES TITLE STEEL WATER LINE REPLACEMENT — PHASE IB LINE "D" PLAN & PROFILE	
APPROVALS	ENGINEER	DATE	APPROVALS
City Engineer			Liquid Waste
ACE Design			Traffic
ACE Hydrology			Water
DRAWING NO.		SHEET 49 OF 63 WR 49	

REFERENCES	SURVEY INFORMATION	FIELD NOTES	DATE	BY	NO	W	O	N	O
MAP NO. K-15-12	DATE 11/79	BY 7/23/98	DATE 11/79	BY 7/23/98	NO	W	O	N	O
EST NO.									
REVISIONS									
NO.	DATE	REMARKS							
DESIGNED BY	DATE	DESIGN							
DRAWN BY	DATE	DRAWN							
CHECKED BY	DATE	CHECKED							

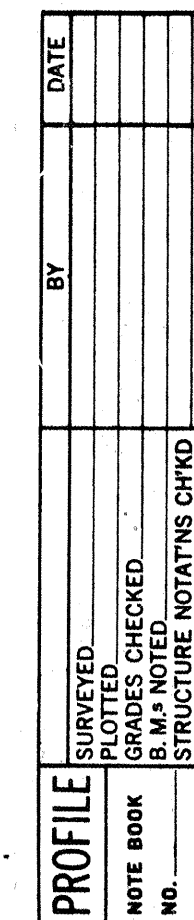

RECORD DRAWING

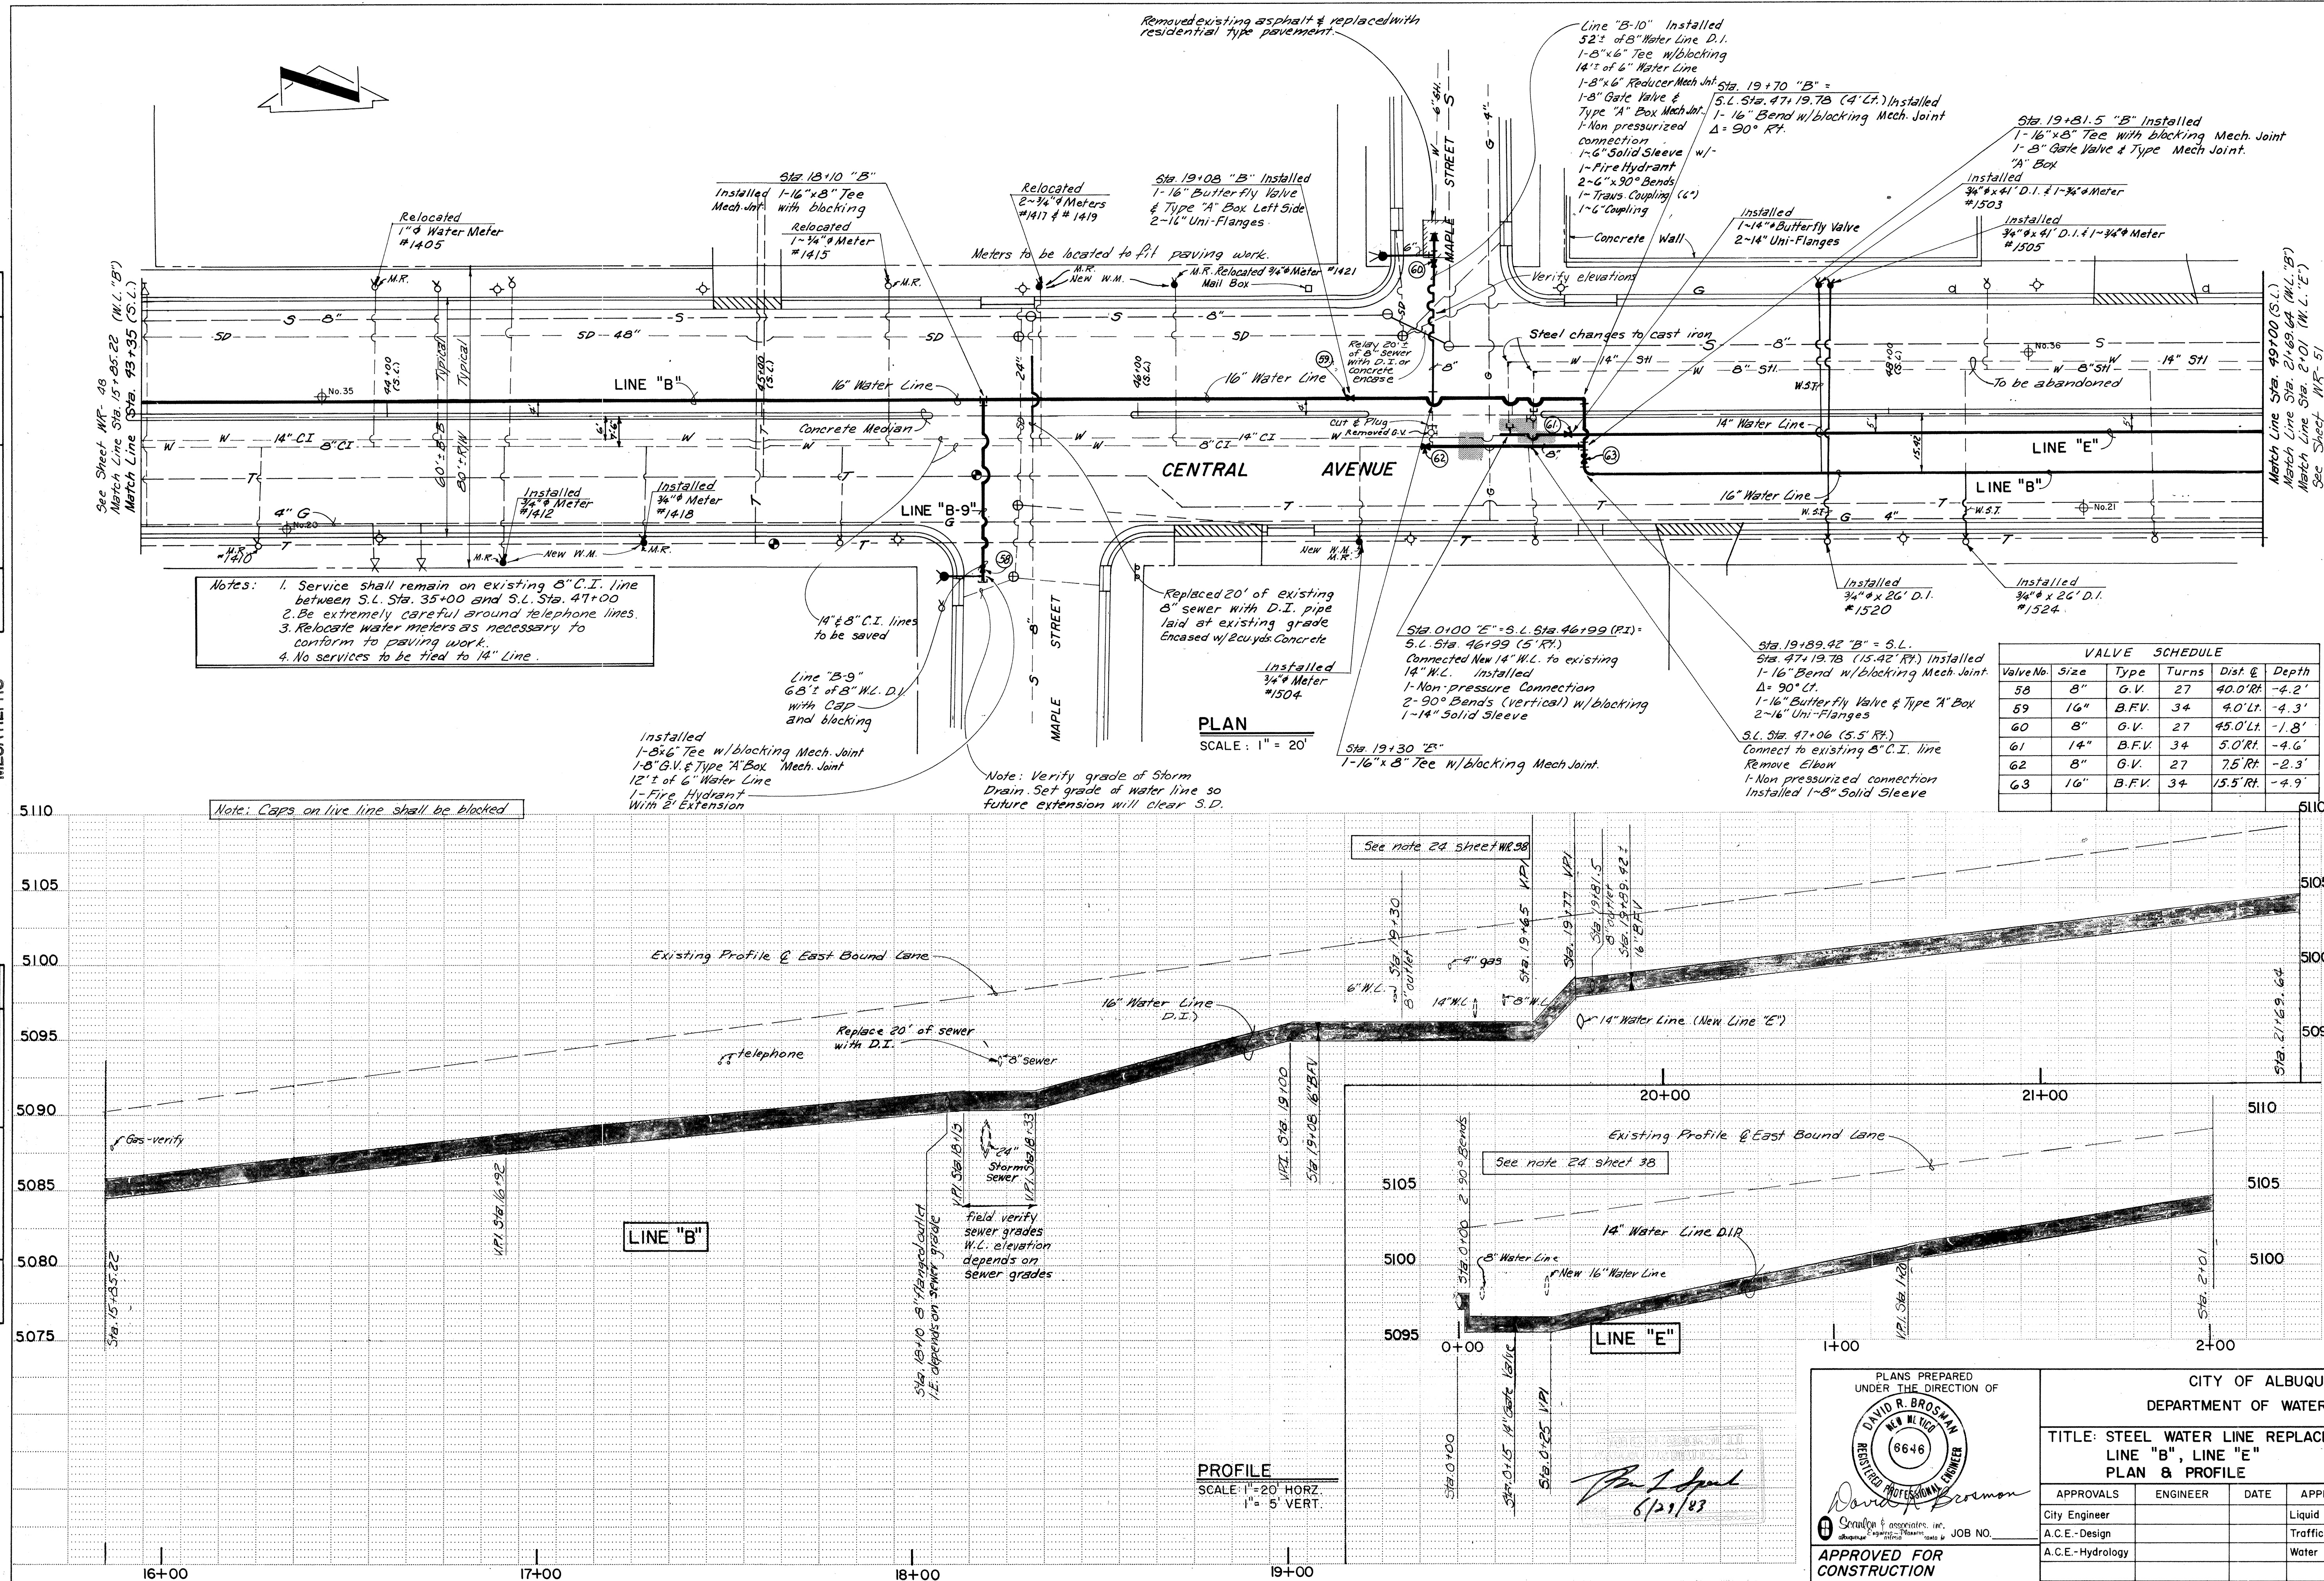
[illegible]

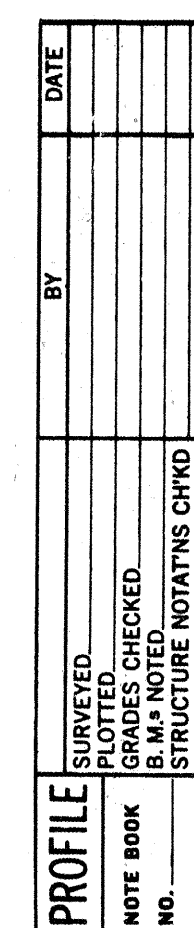

Valve No.	Size	Type	Turns	Dist. @	Depth
G4	8"	G.V.	27	95.0' Lt.	-5.0'
G5	16"	B.F.V.	34	15.5' Rt.	-2.9'
G6	8"	G.V.	27	45.0' Lt.	-3.2'
G7	6"	G.V.	21	14.0' Rt.	-5.1'
G8	8"	G.V.	27	45.0' Rt.	-1.8'

RECORD DRAWING

 PLANS PREPARED
UNDER THE DIRECTION OF



David L. Brozman

Sealman & Associates, Inc.
Professional Engineers
10000 1st Avenue, N.E. Albuquerque, N.M. 87111

APPROVED FOR CONSTRUCTION


CITY ENGINEER
DATE

CITY OF ALBUQUERQUE
DEPARTMENT OF WATER RESOURCES

TITLE: STEEL WATER LINE REPLACEMENT - PHASE 1B
LINE "B", LINE "E"
PLAN & PROFILE


APPROVALS	ENGINEER	DATE	APPROVALS	ENGINEER	DATE
City Engineer			Liquid Waste		
A.C.E. - Design			Traffic		
A.C.E. - Hydrology			Water		
DRAWING NO.			SHEET 51 OF 63		
			WR		

SCANNED BY
MESA REPRO

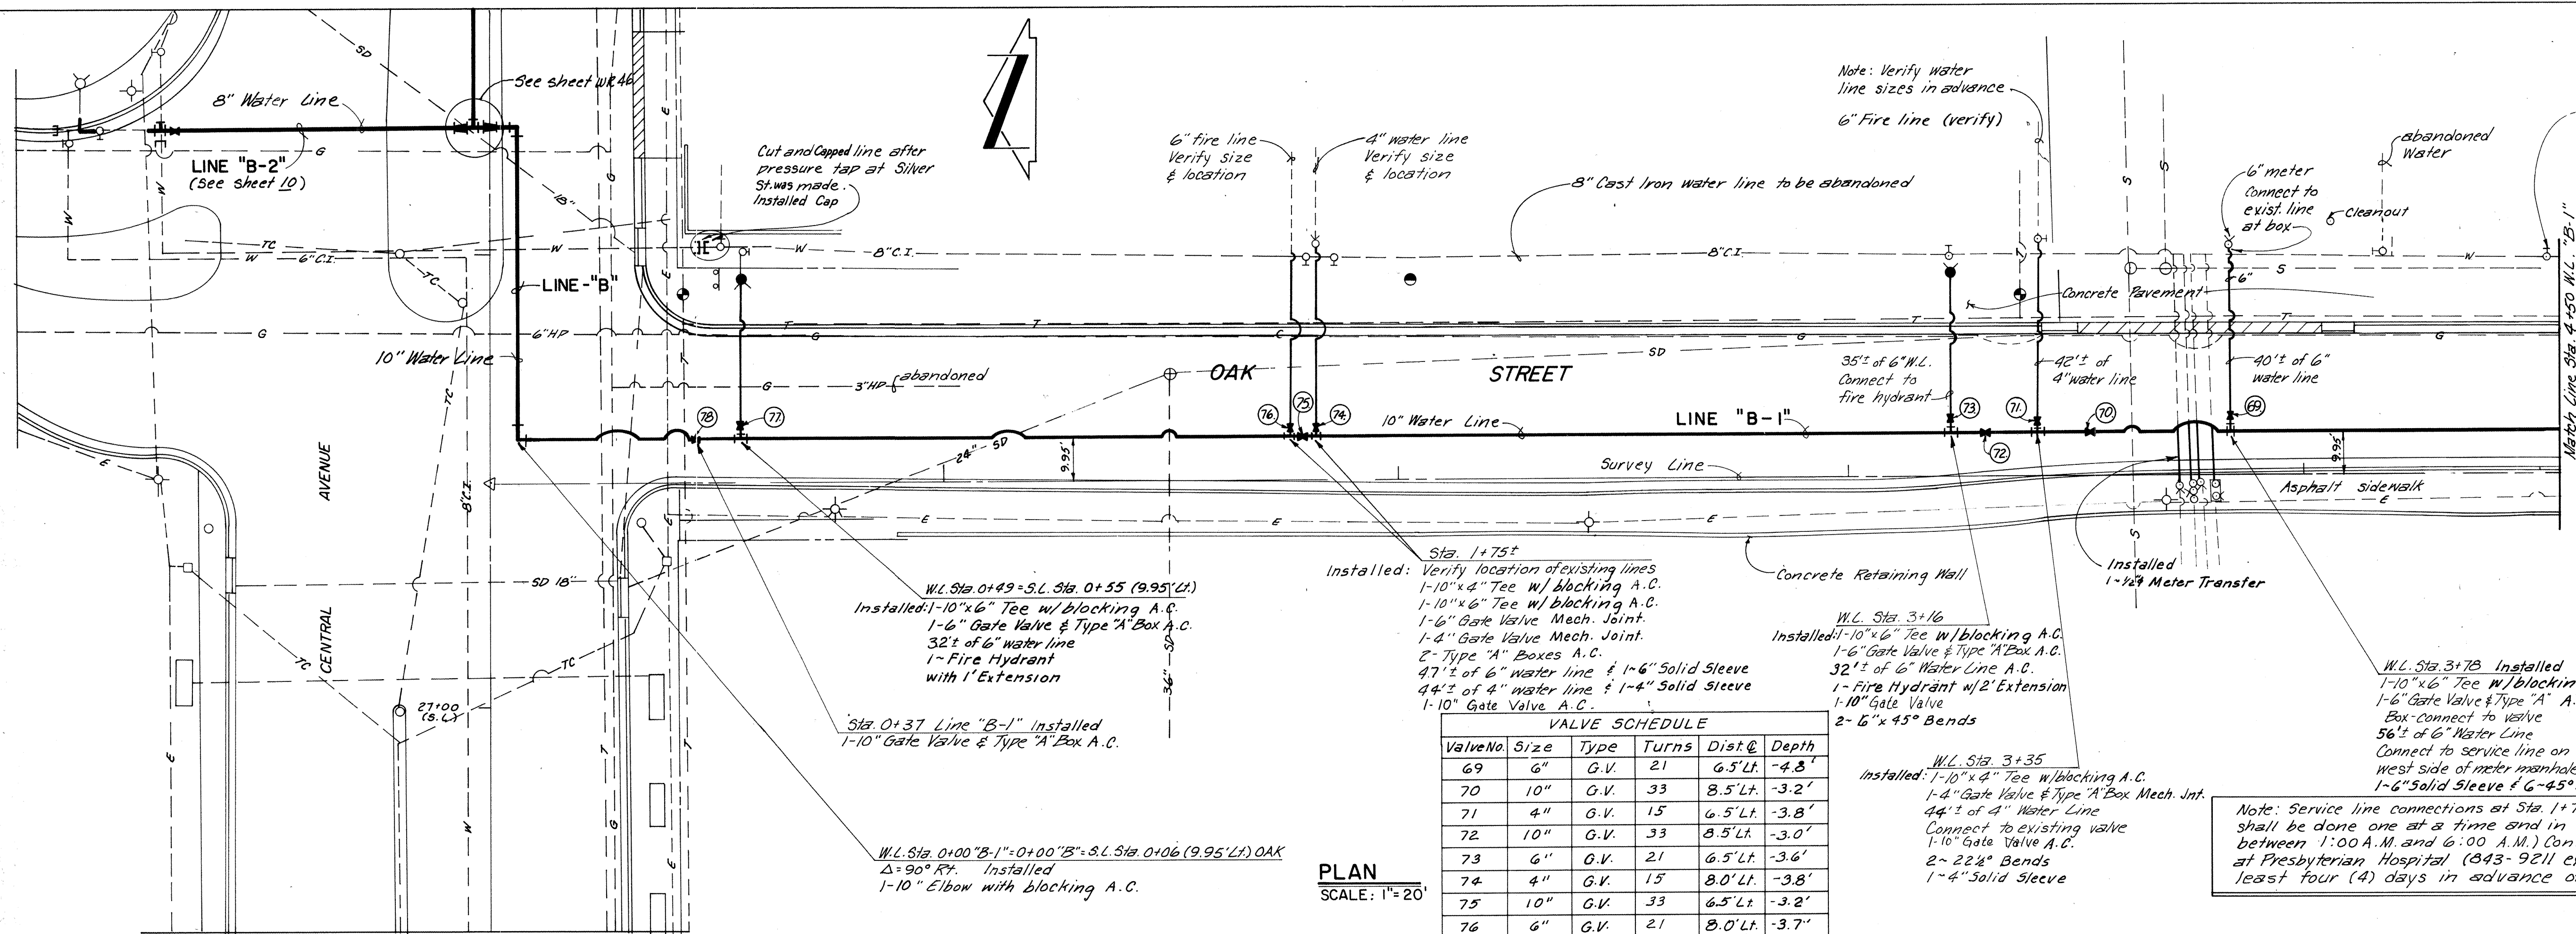


Valve No.	Size	Type	Turns	Dist. @	Depth
69	6"	G.V.	21	6.5' Lt.	-4.8'
70	10"	G.V.	33	8.5' Lt.	-3.2'
71	4"	G.V.	15	6.5' Lt.	-3.8'
72	10"	G.V.	33	8.5' Lt.	-3.0'
73	6"	G.V.	21	6.5' Lt.	-3.6'
74	4"	G.V.	15	8.0' Lt.	-3.8'
75	10"	G.V.	33	6.5' Lt.	-3.2'
76	6"	G.V.	21	8.0' Lt.	-3.7'
77	6"	G.V.	21	8.0' Lt.	-4.6'
78	10"	G.V.	33	6.5' Lt.	-4.2'

Note: Service line connections at Sta. 1+75¹ and Sta. 3+35 shall be done one at a time and in late hours (i.e., between 1:00 A.M. and 6:00 A.M.) Contact Kevin McNullen at Presbyterian Hospital (843- 9211 extension 3990) at least four (4) days in advance of connection.

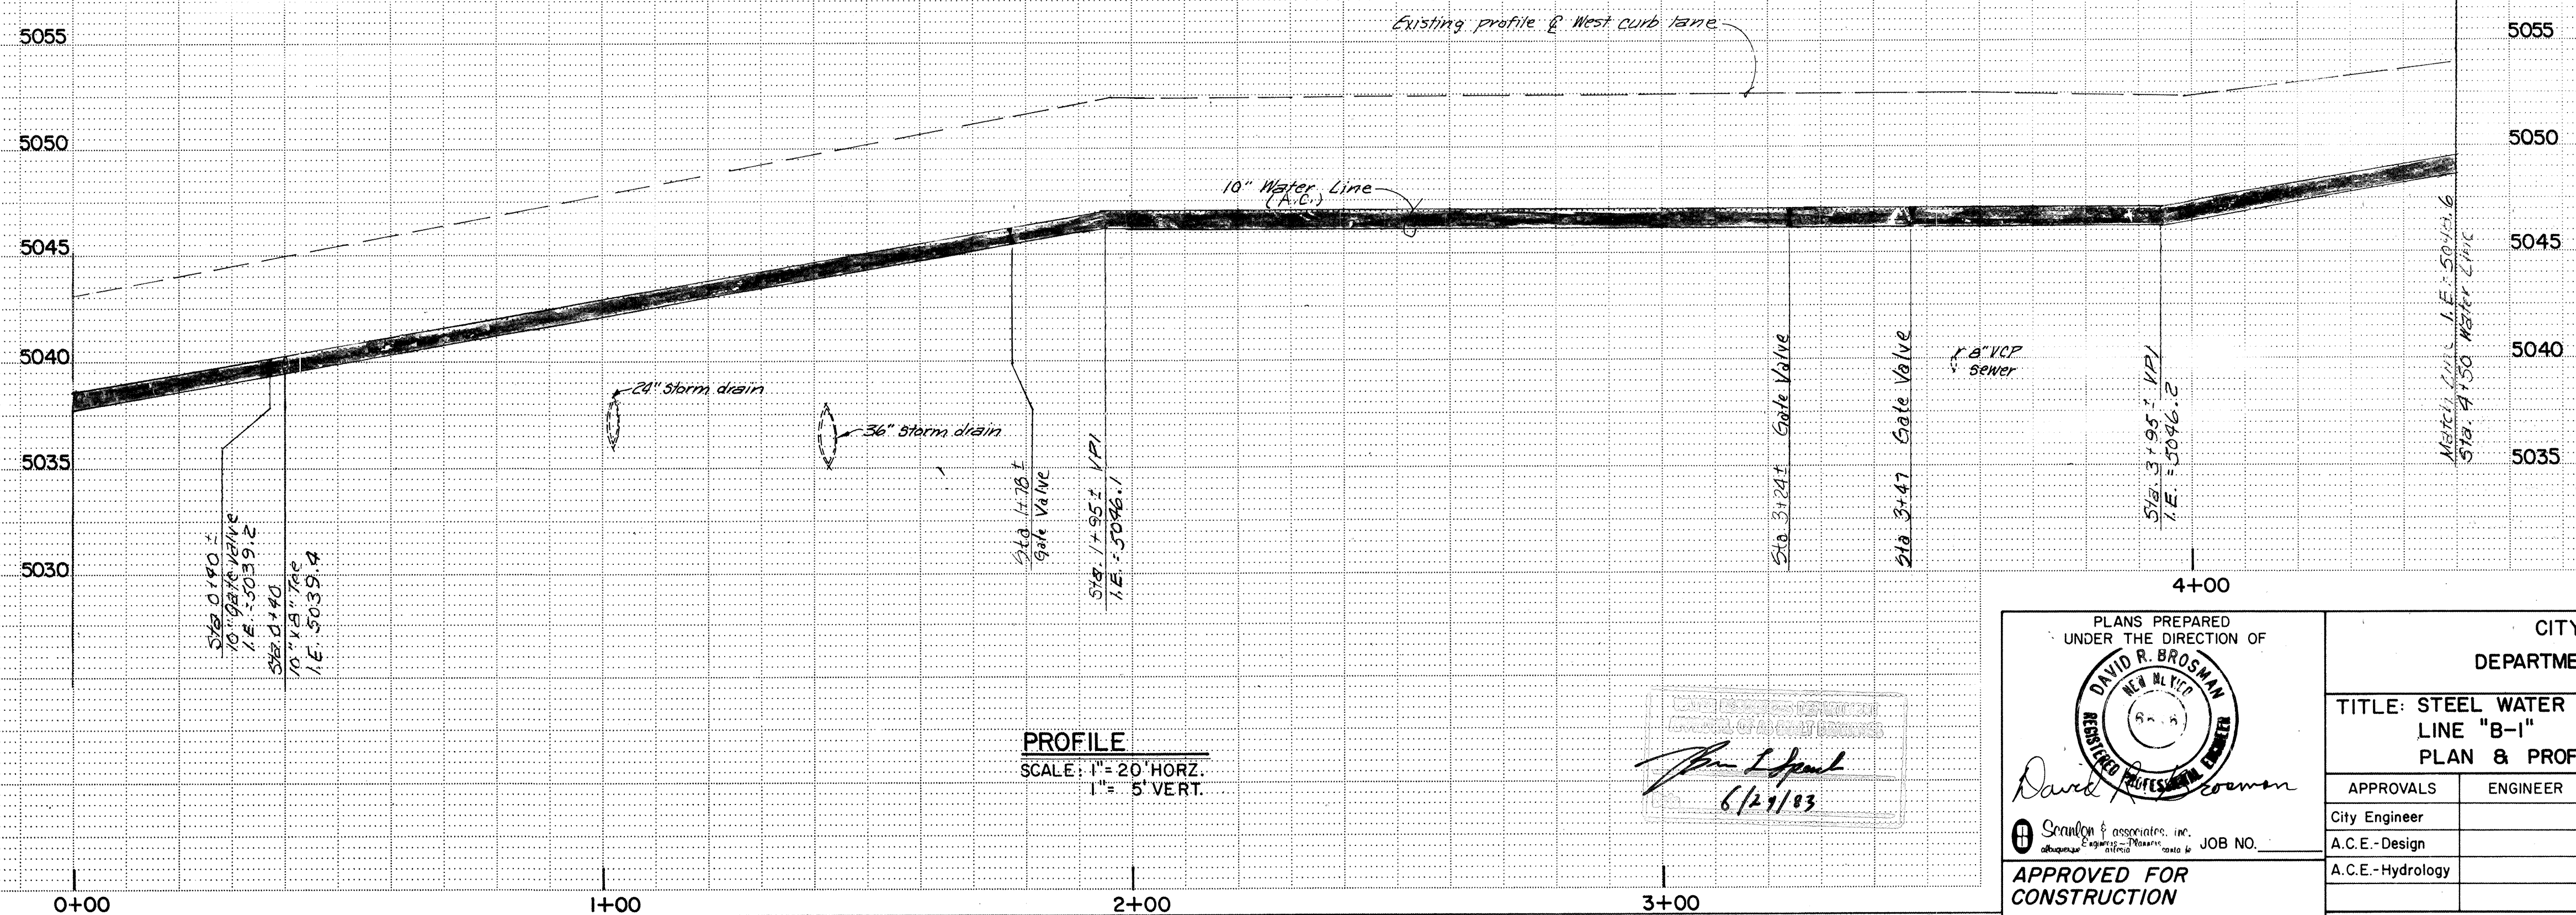

PROFILE
SCALE: 1" = 20' HORZ.
1" = 5' VERT.

 RECORD DRAWING

PLANS PREPARED UNDER THE DIRECTION OF  <i>David R. Brosman</i>	CITY OF ALBUQUERQUE DEPARTMENT OF WATER RESOURCES TITLE: STEEL WATER LINE REPLACEMENT — PHASE 1B LINE "B-1" PLAN & PROFILE																														
APPROVED FOR CONSTRUCTION CITY ENGINEER	<table border="1" style="width: 100%; border-collapse: collapse;"> <tr> <th style="width: 25%;">APPROVALS</th> <th style="width: 25%;">ENGINEER</th> <th style="width: 25%;">DATE</th> <th style="width: 25%;">APPROVALS</th> <th style="width: 25%;">ENGINEER</th> <th style="width: 25%;">DATE</th> </tr> <tr> <td>City Engineer</td> <td></td> <td></td> <td>Liquid Waste</td> <td></td> <td></td> </tr> <tr> <td>A.C.E. — Design</td> <td></td> <td></td> <td>Traffic</td> <td></td> <td></td> </tr> <tr> <td>A.C.E. — Hydrology</td> <td></td> <td></td> <td>Water</td> <td></td> <td></td> </tr> <tr> <td></td> <td></td> <td></td> <td></td> <td></td> <td></td> </tr> </table> DRAWING NO.	APPROVALS	ENGINEER	DATE	APPROVALS	ENGINEER	DATE	City Engineer			Liquid Waste			A.C.E. — Design			Traffic			A.C.E. — Hydrology			Water								
APPROVALS	ENGINEER	DATE	APPROVALS	ENGINEER	DATE																										
City Engineer			Liquid Waste																												
A.C.E. — Design			Traffic																												
A.C.E. — Hydrology			Water																												
JOB NO.	SHEET 52 OF 63 WR																														


PLAN

SURVEYED	BY	DATE
ALIGNED		
CONTRACT CHECKED		
RT. OF WAY CHECKED		
NOTE BOOK NO.		

SCANNED BY
MESA REPRO


PROFILE

SURVEYED	BY	DATE
GRADES CHECKED		
STRUCTURE NOTATIONS CHKD		
NOTE BOOK NO.		

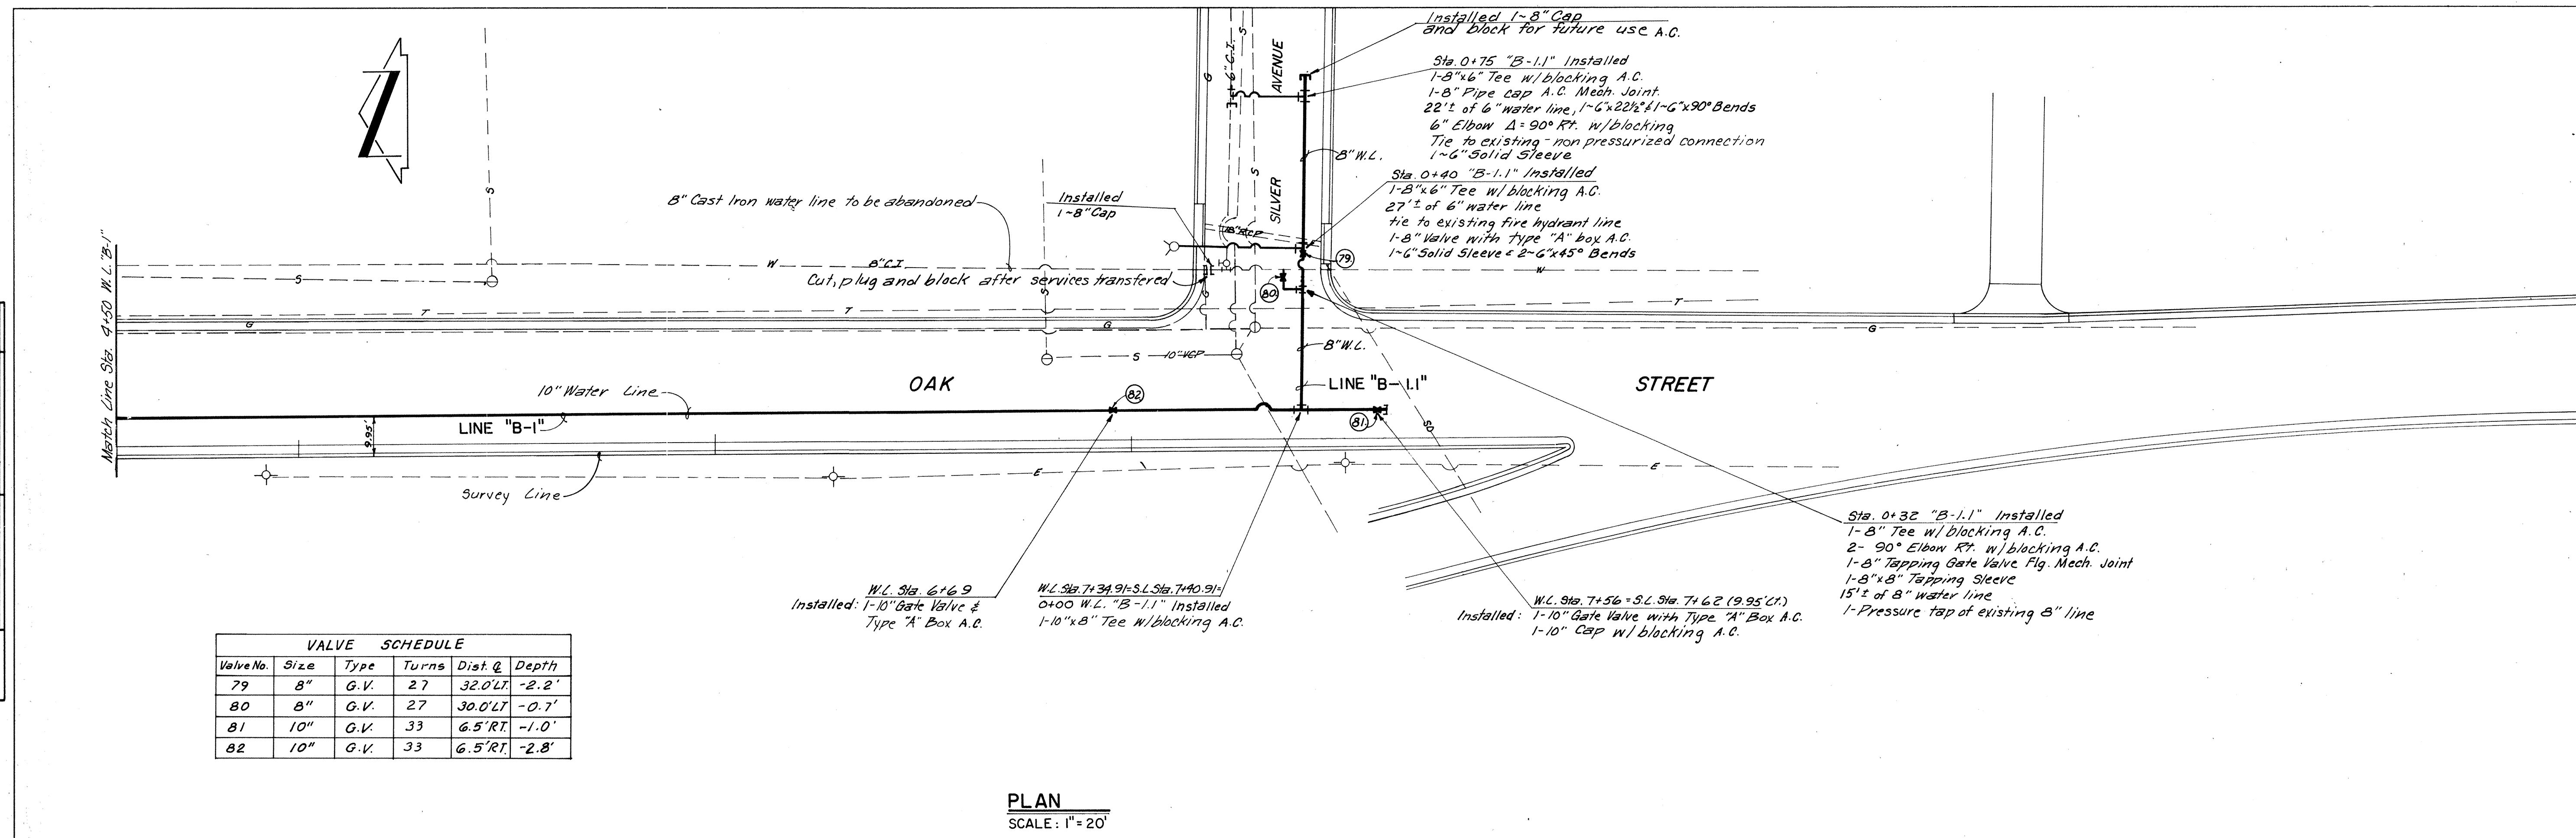

VALVE SCHEDULE					
Valve No.	Size	Type	Turns	Dist. &	Depth
79	8"	G.V.	27	32.0' LT	-2.2'
80	8"	G.V.	27	30.0' LT	-0.7'
81	10"	G.V.	33	6.5' RT	-1.0'
82	10"	G.V.	33	6.5' RT	-2.8'



PLAN
SCALE: 1" = 20'

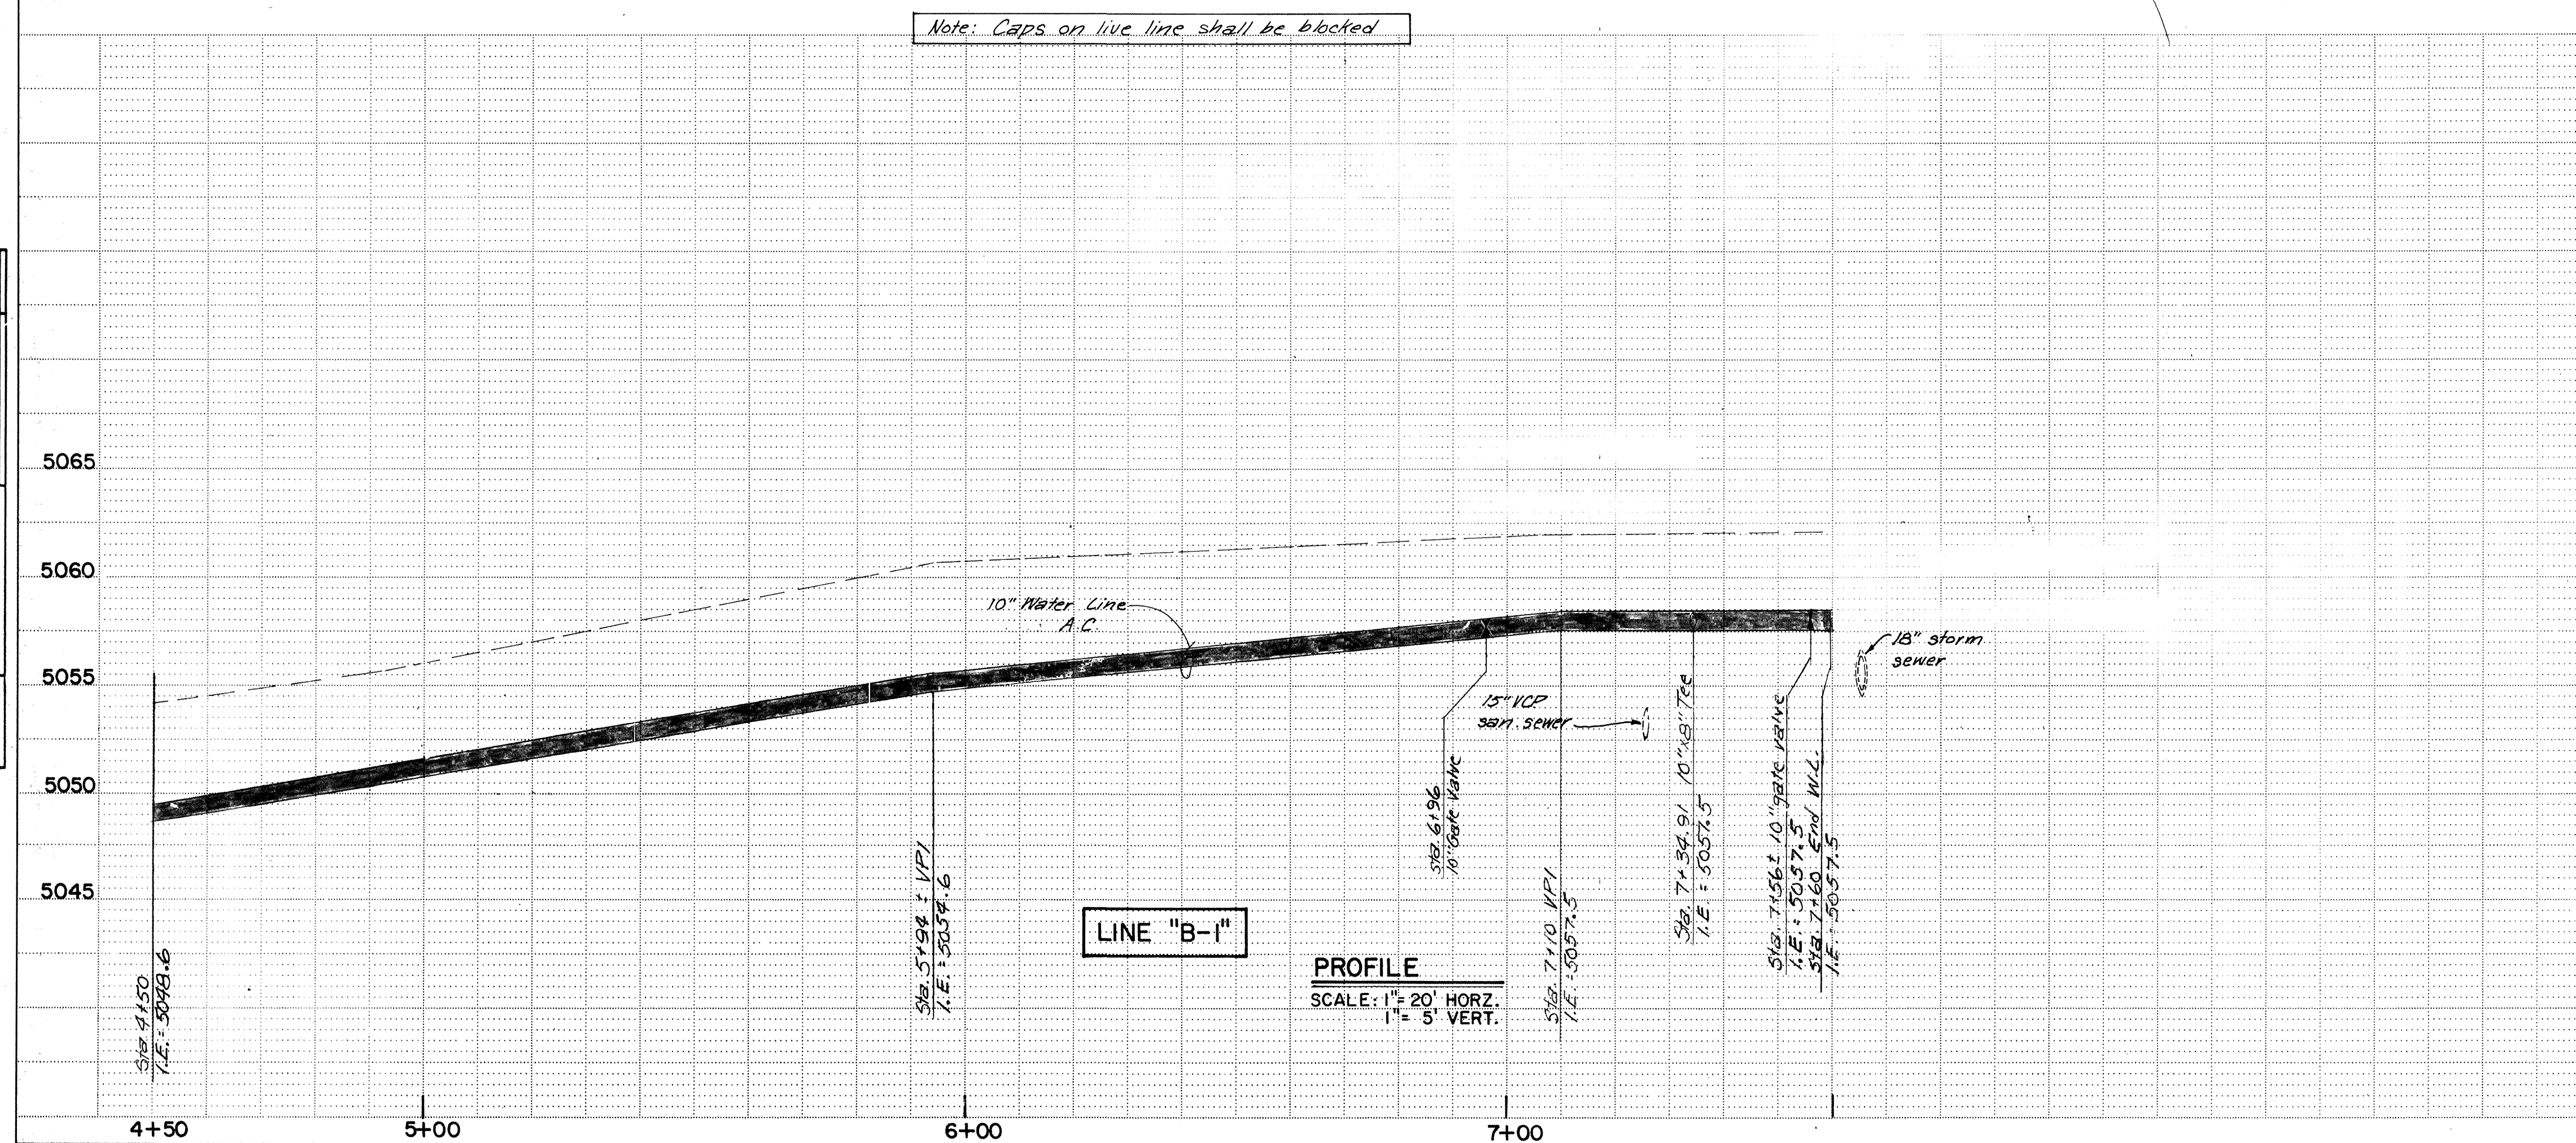

PROFILE
SCALE: 1" = 20' HORZ.
1" = 5' VERT.

PLANS PREPARED UNDER THE DIRECTION OF		CITY OF ALBUQUERQUE DEPARTMENT OF WATER RESOURCES	
APPROVED FOR CONSTRUCTION		TITLE: STEEL WATER LINE REPLACEMENT - PHASE 1B LINE "B-1" PLAN & PROFILE	
CITY ENGINEER	DATE	APPROVALS	ENGINEER
		Liquid Waste	
		Traffic	
		Water	
DRAWING NO.		SHEET 53 OF 63 WR	



SCANNED BY
MESA REPRO

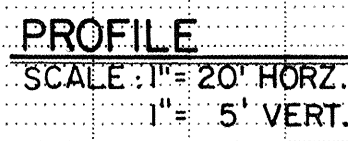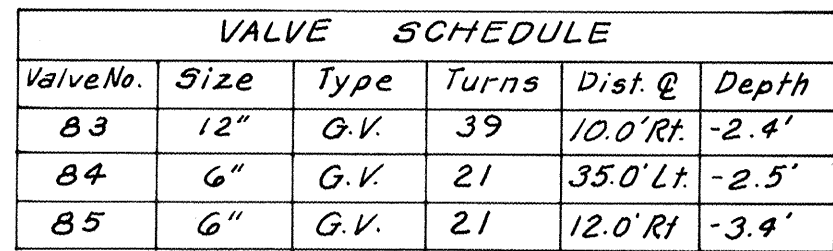


RECORD DRAWING

[illegible]

PROFILE	SURVEYED _____		BY _____	DATE _____
	NOTE BOOK	PLOTTED _____ GRADES CHECKED _____ B. M.'s NOTED _____ STRUCTURE NOTATIONS CURED _____		

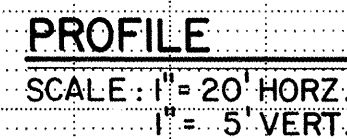 


RECORD DRAWING

 PLANS PREPARED UNDER THE DIRECTION OF  <i>David R. Brown</i> Sealed & Associates, Inc. Engineers & Architects Albuquerque, New Mexico APPROVED FOR CONSTRUCTION CITY ENGINEER DATE	CITY OF ALBUQUERQUE DEPARTMENT OF WATER RESOURCES TITLE: STEEL WATER LINE REPLACEMENT – PHASE 1B LINE "B-8" PLAN & PROFILE <table border="1" style="width: 100%; border-collapse: collapse;"> <tr> <th style="width: 25%;">APPROVALS</th> <th style="width: 25%;">ENGINEER</th> <th style="width: 25%;">DATE</th> <th style="width: 25%;">APPROVALS</th> <th style="width: 25%;">ENGINEER</th> <th style="width: 25%;">DATE</th> </tr> <tr> <td>City Engineer</td> <td></td> <td></td> <td>Liquid Waste</td> <td></td> <td></td> </tr> <tr> <td>A.C.E. - Design</td> <td></td> <td></td> <td>Traffic</td> <td></td> <td></td> </tr> <tr> <td>A.C.E. - Hydrology</td> <td></td> <td></td> <td>Water</td> <td></td> <td></td> </tr> <tr> <td> </td> <td> </td> <td> </td> <td> </td> <td> </td> <td> </td> </tr> </table> DRAWING NO.	APPROVALS	ENGINEER	DATE	APPROVALS	ENGINEER	DATE	City Engineer			Liquid Waste			A.C.E. - Design			Traffic			A.C.E. - Hydrology			Water								
APPROVALS	ENGINEER	DATE	APPROVALS	ENGINEER	DATE																										
City Engineer			Liquid Waste																												
A.C.E. - Design			Traffic																												
A.C.E. - Hydrology			Water																												

PLAN	DATE
BY	
SURVEYED	
ALIGNED	
RT. OF WAY	
NO.	

SCANNED BY
MEGA REPRO


PROFILE	DATE
BY	
SURVEYED	
GRADES	
NO.	

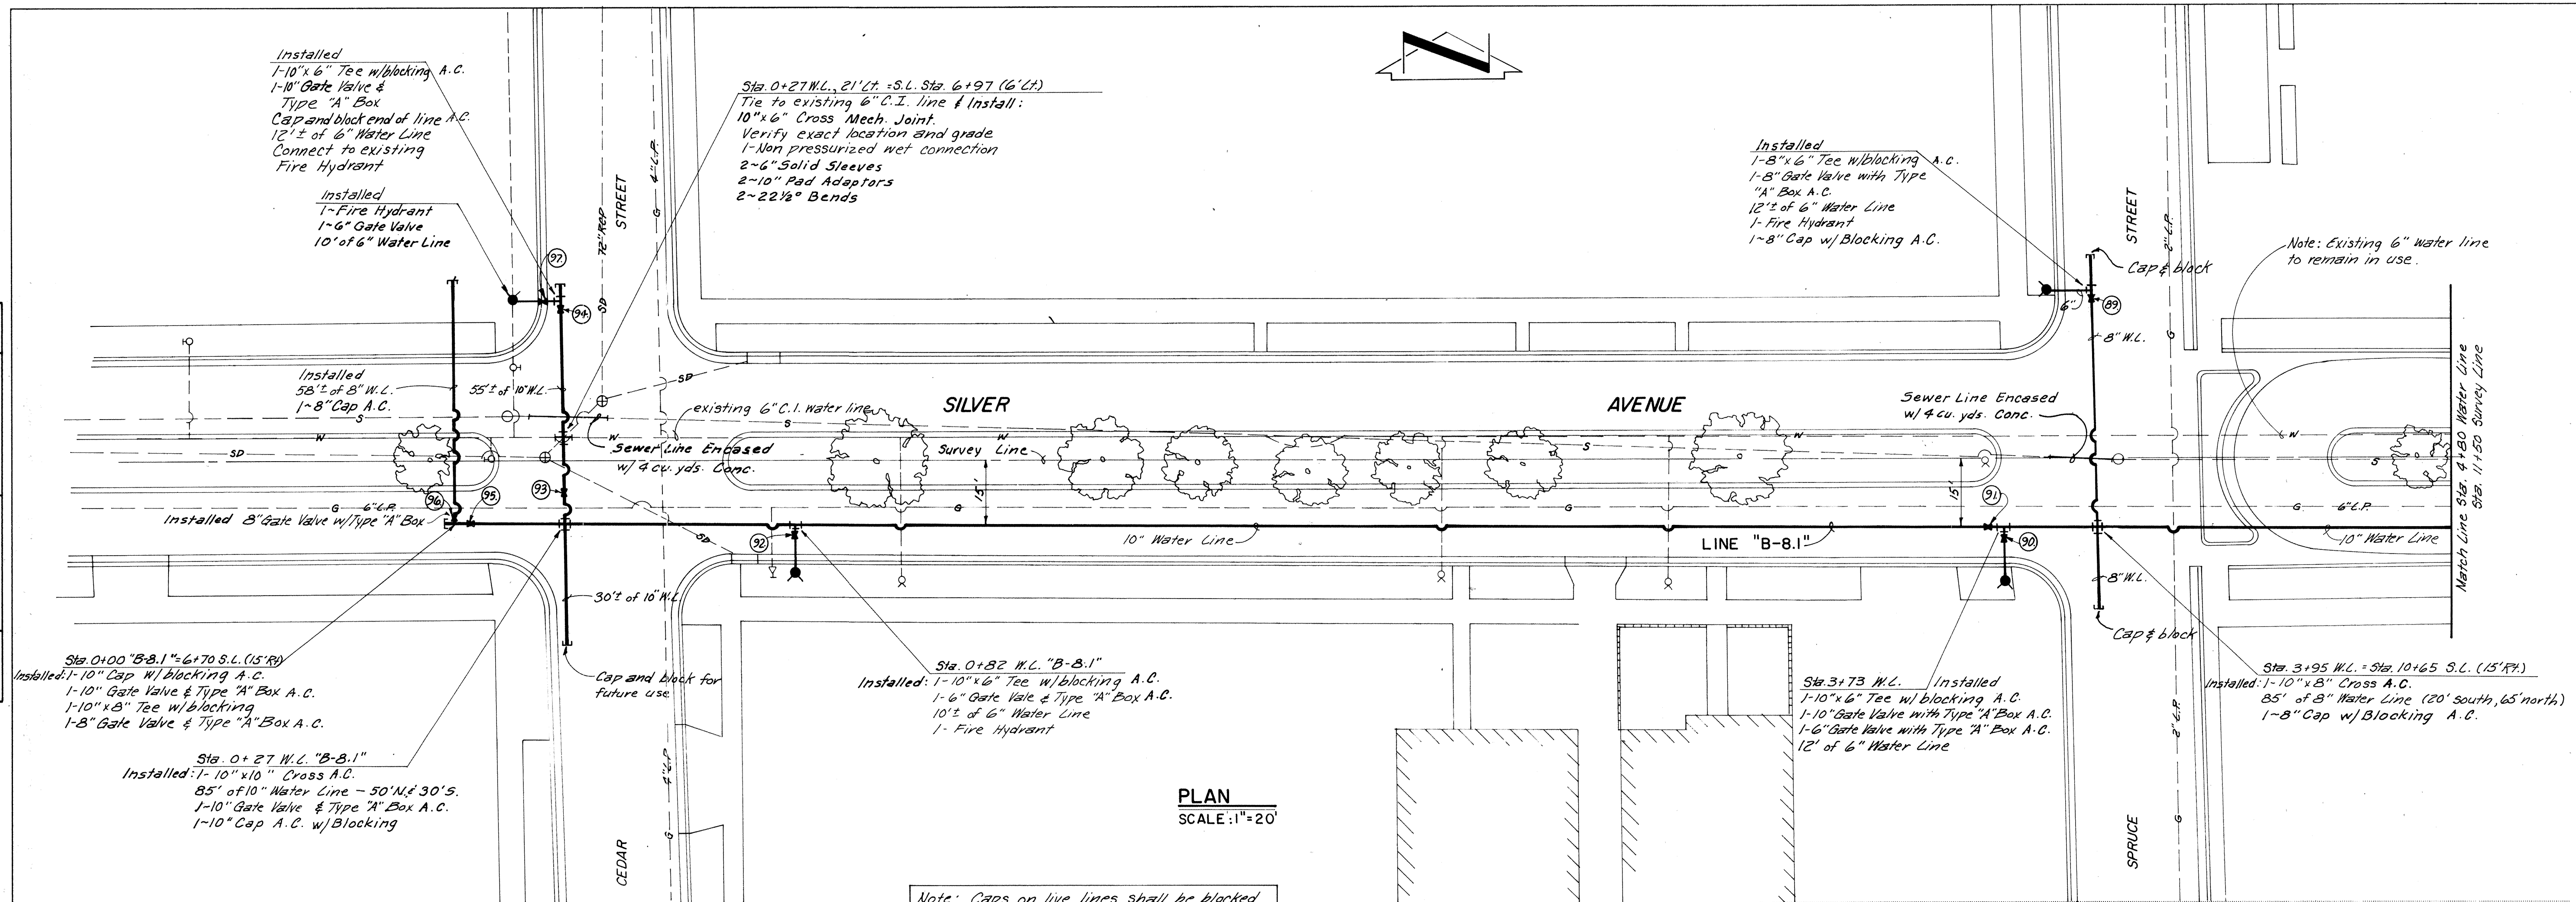

PLAN
SCALE: 1"=20'

VALVE SCHEDULE					
Valve No.	Size	Type	Turns	Dist. @	Depth
89	8"	O.V.	27	35.0' Lt.	-1.3'
90	6"	G.V.	21	16.5' Rt.	-2.2'
91	10"	O.V.	33	15.0' Rt.	-1.7'
92	6"	O.V.	21	16.5' Rt.	-2.4'
93	10"	O.V.	33	7.0' Rt.	-1.5'
94	10"	O.V.	33	13.5' Lt.	-1.5'
95	10"	O.V.	33	15.0' Rt.	-1.8'
96	8"	G.V.	8	36.0' Lt.	-2.5'
97	6"	O.V.	6	37.0' Lt.	-2.1'

Note: Caps on live lines shall be blocked

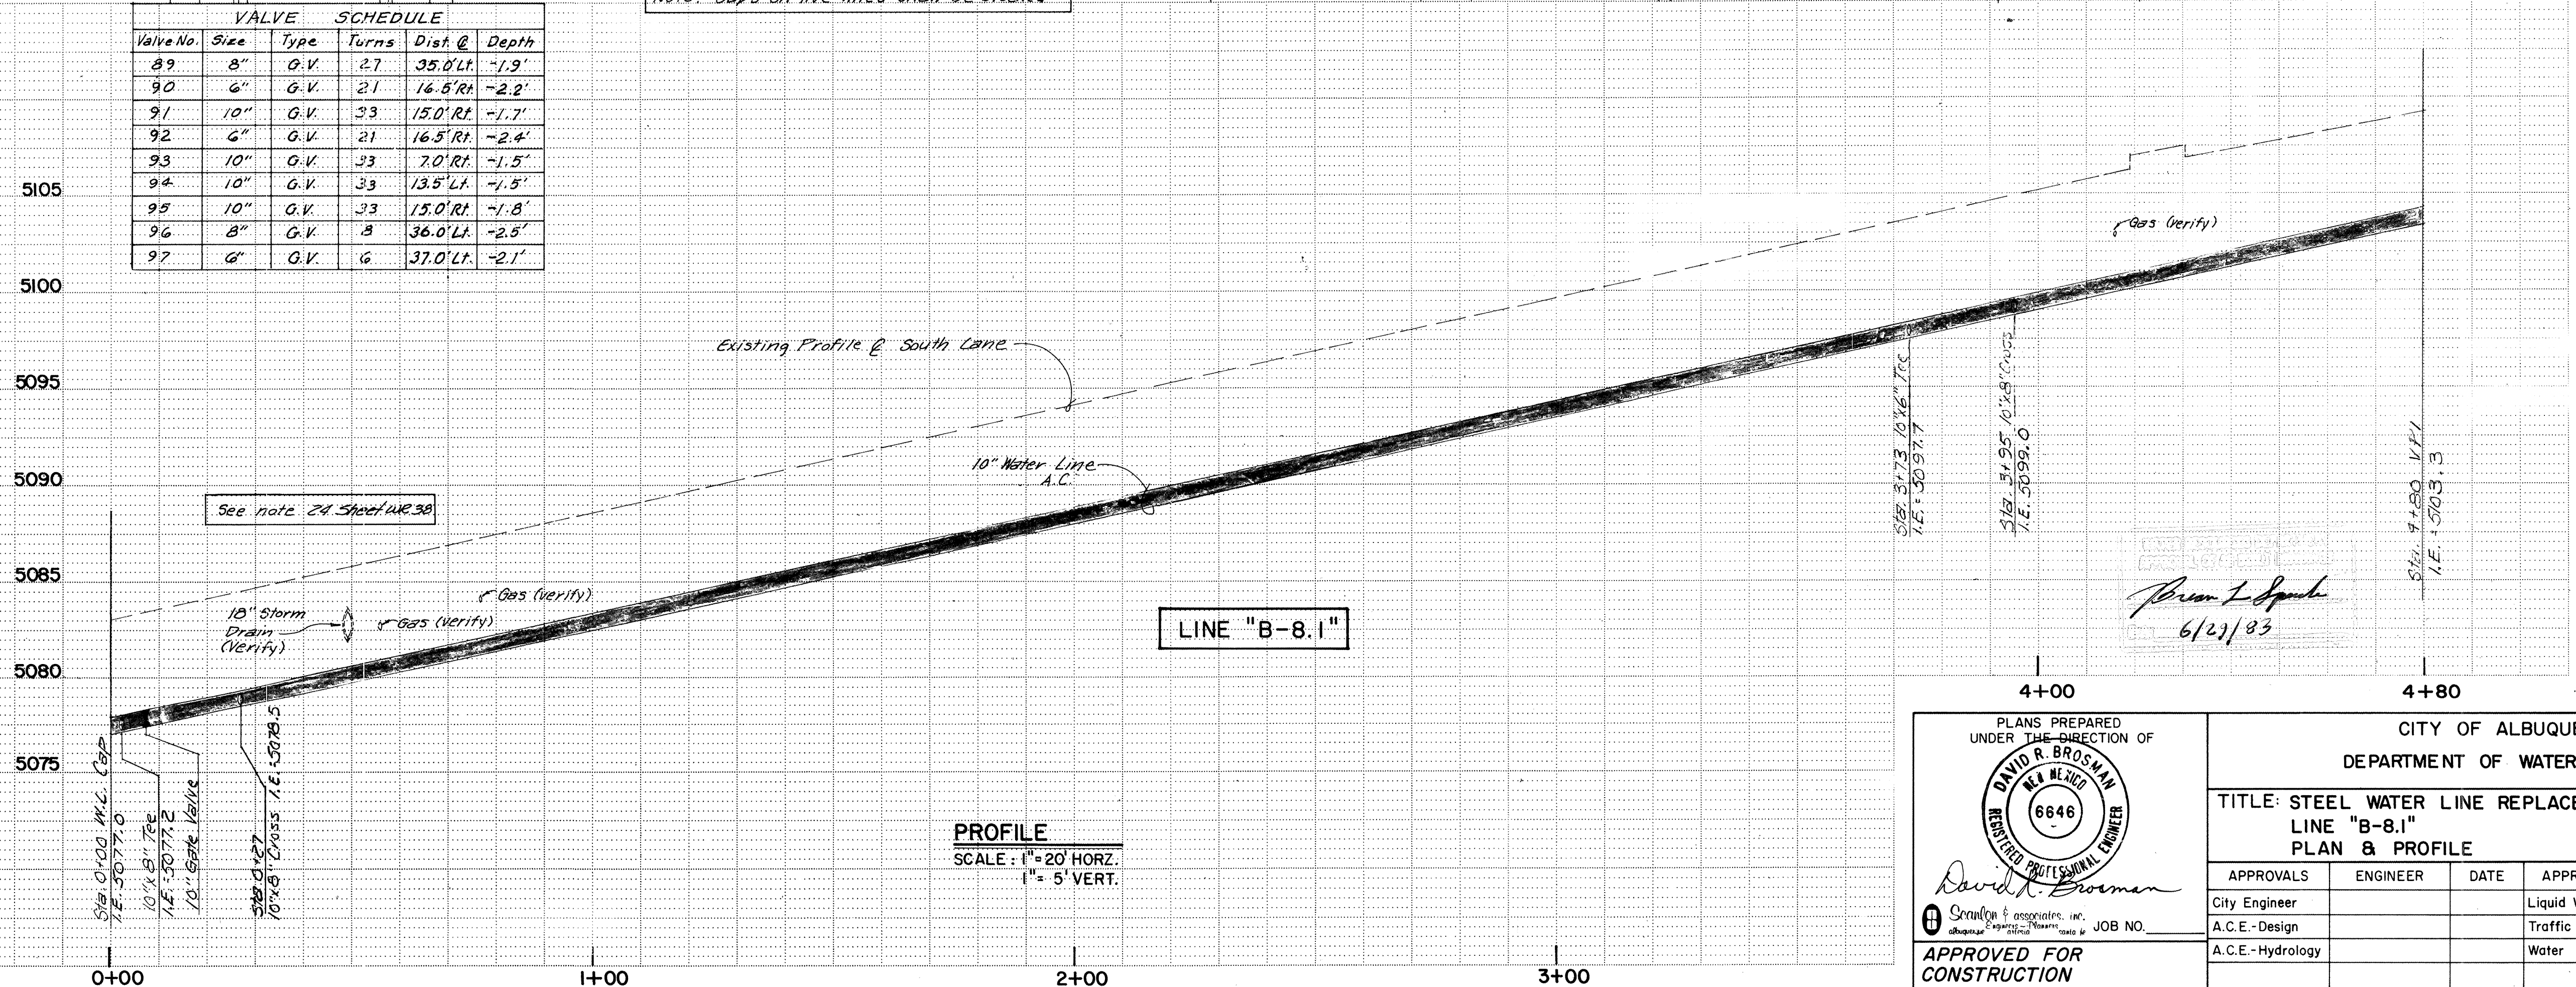

PROFILE
SCALE: 1"=20' HORIZ.
1"=5' VERT.


PLANS PREPARED
UNDER THE DIRECTION OF
DAVID R. BROSMAN
REGISTERED PROFESSIONAL ENGINEER
6646
APPROVED FOR
CONSTRUCTION
CITY ENGINEER DATE

CITY OF ALBUQUERQUE
DEPARTMENT OF WATER RESOURCES
TITLE: STEEL WATER LINE REPLACEMENT - PHASE 1B
LINE "B-8.1"
PLAN & PROFILE

APPROVALS	ENGINEER	DATE	APPROVALS	ENGINEER	DATE
City Engineer			Liquid Waste		
A.C.E.-Design			Traffic		
A.C.E.-Hydrology			Water		

DRAWING NO. SHEET 56 OF 63
WR

SCANNED BY
MESA REPRO

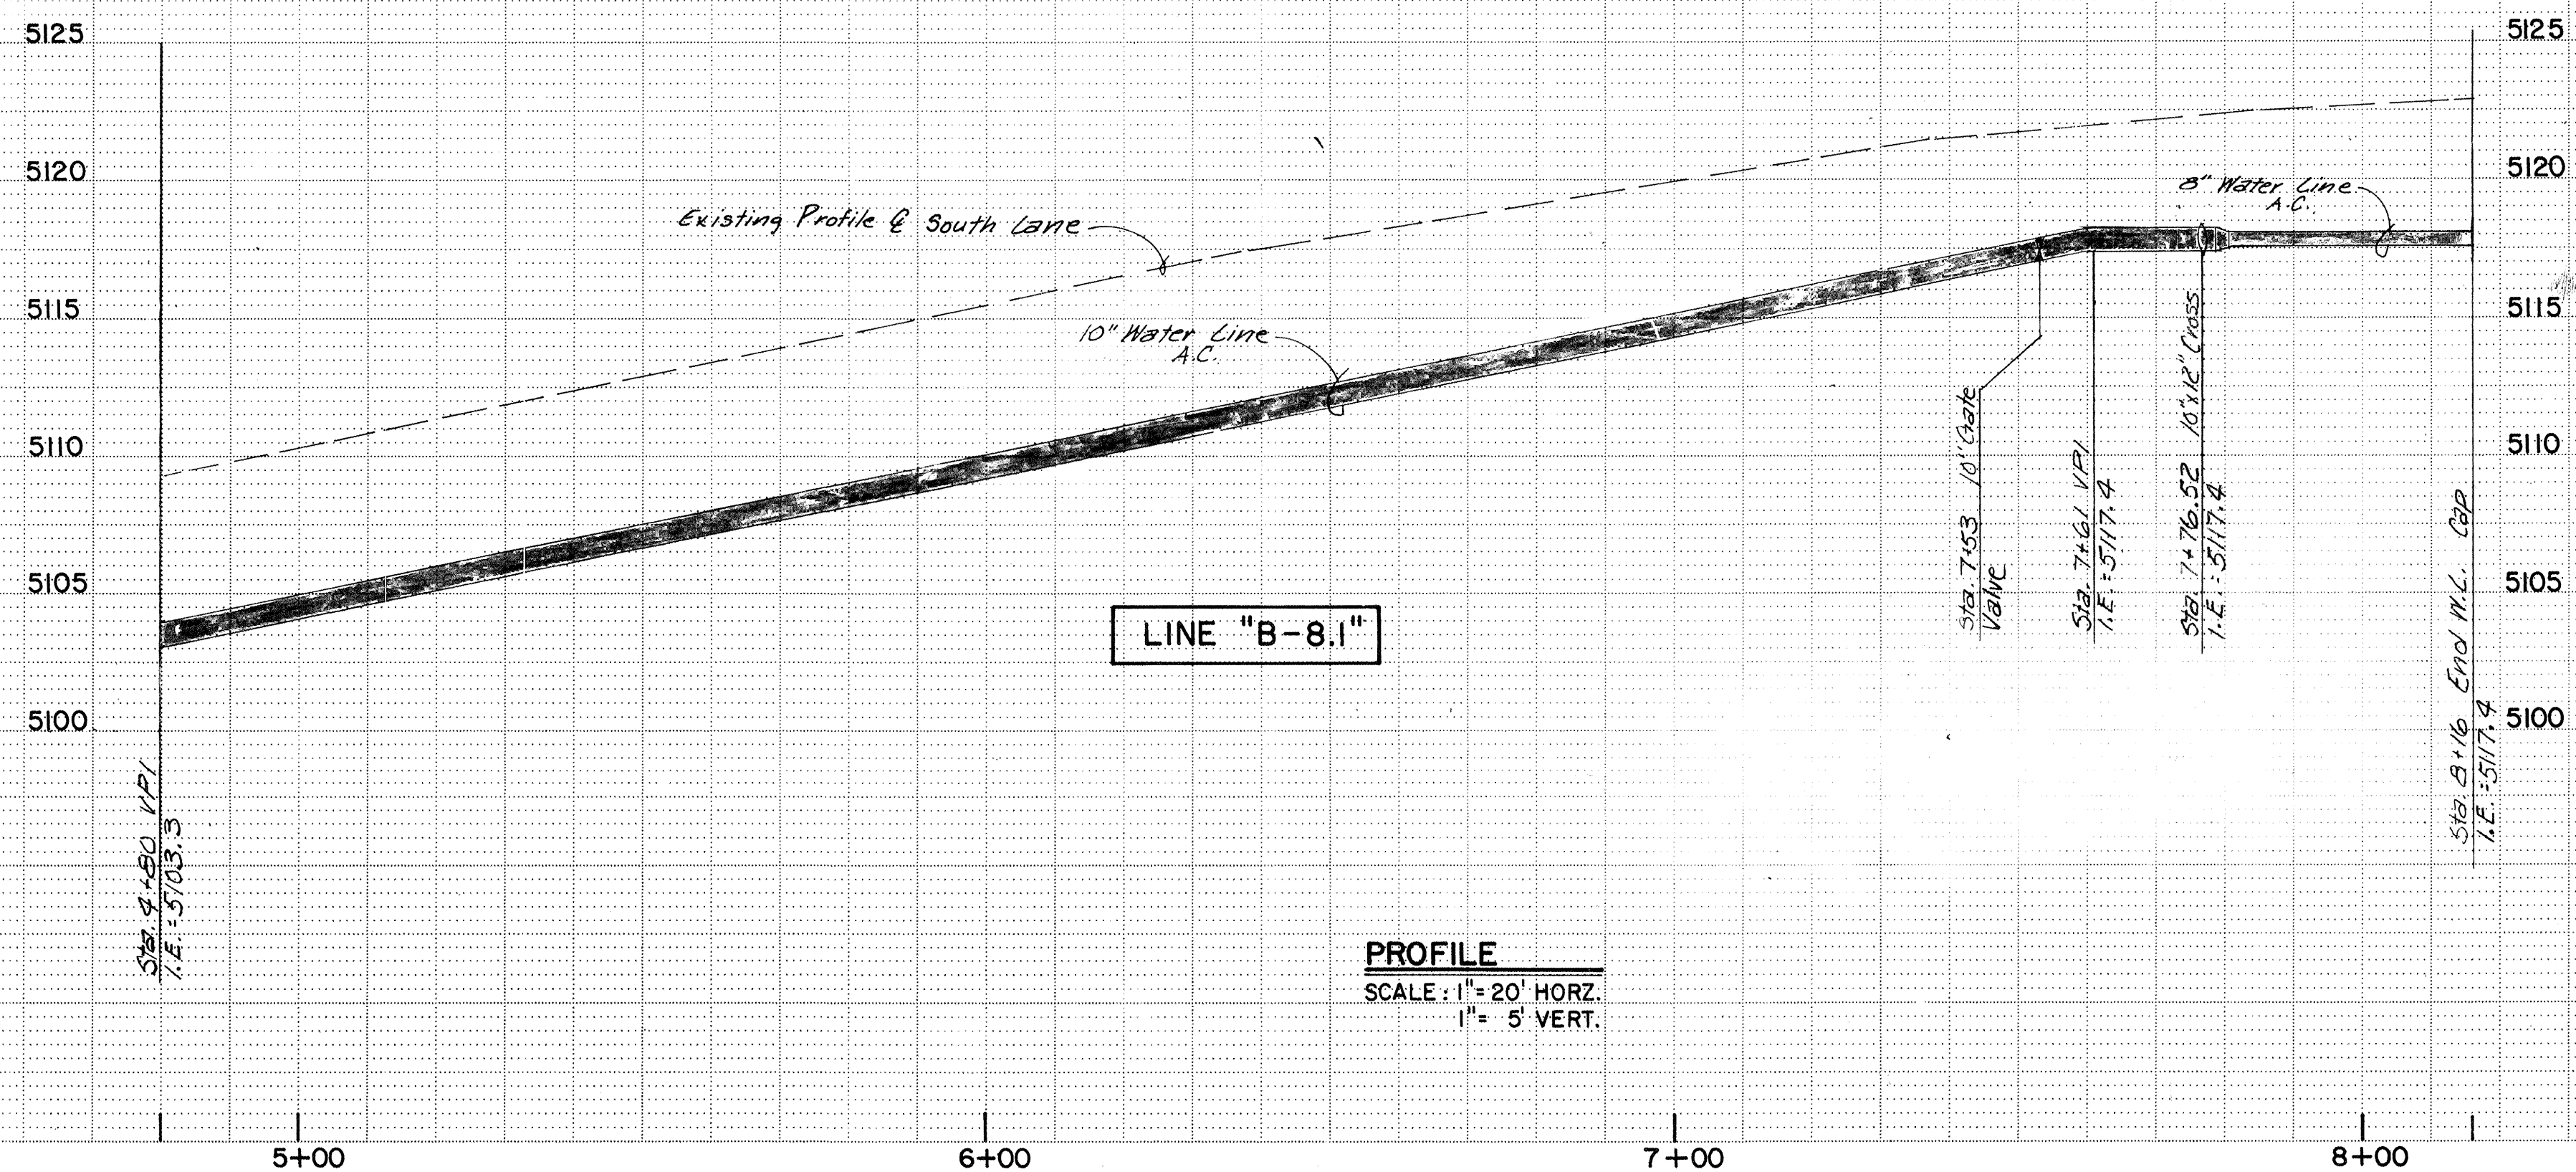

RECORD DRAWING

PLANS PREPARED UNDER THE DIRECTION OF  <i>David R. Brown</i> Scrutiny & Associates, Inc. Engineers, Architects, Planners, and Environmental Scientists JOB NO. _____	CITY OF ALBUQUERQUE DEPARTMENT OF WATER RESOURCES TITLE: STEEL WATER LINE REPLACEMENT - PHASE 1B LINE "B-8.1" PLAN & PROFILE <table border="1" style="width: 100%; border-collapse: collapse;"> <thead> <tr> <th style="width: 25%;">APPROVALS</th> <th style="width: 25%;">ENGINEER</th> <th style="width: 25%;">DATE</th> <th style="width: 25%;">APPROVALS</th> <th style="width: 25%;">ENGINEER</th> <th style="width: 25%;">DATE</th> </tr> </thead> <tbody> <tr> <td>City Engineer</td> <td></td> <td></td> <td>Liquid Waste</td> <td></td> <td></td> </tr> <tr> <td>A.C.E. - Design</td> <td></td> <td></td> <td>Traffic</td> <td></td> <td></td> </tr> <tr> <td>A.C.E. - Hydrology</td> <td></td> <td></td> <td>Water</td> <td></td> <td></td> </tr> <tr> <td> </td> <td> </td> <td> </td> <td> </td> <td> </td> <td> </td> </tr> </tbody> </table>	APPROVALS	ENGINEER	DATE	APPROVALS	ENGINEER	DATE	City Engineer			Liquid Waste			A.C.E. - Design			Traffic			A.C.E. - Hydrology			Water								
APPROVALS	ENGINEER	DATE	APPROVALS	ENGINEER	DATE																										
City Engineer			Liquid Waste																												
A.C.E. - Design			Traffic																												
A.C.E. - Hydrology			Water																												
APPROVED FOR CONSTRUCTION CITY ENGINEER DATE	DRAWING NO. SHEET 57 OF 63 WR																														