


INDEX

DESCRIPTION	SHEET NO.
COVER	1
GENERAL NOTES	2
DEMOLITION PLAN	3
KINLEY STORM DRAIN PLAN & PROFILE STA 10+00 TO 20+00	4
KINLEY STORM DRAIN PLAN & PROFILE STA 20+00 TO 28+37.62	5
WALTER LATERAL PLAN & PROFILE	6
MISCELLANEOUS DETAILS	7

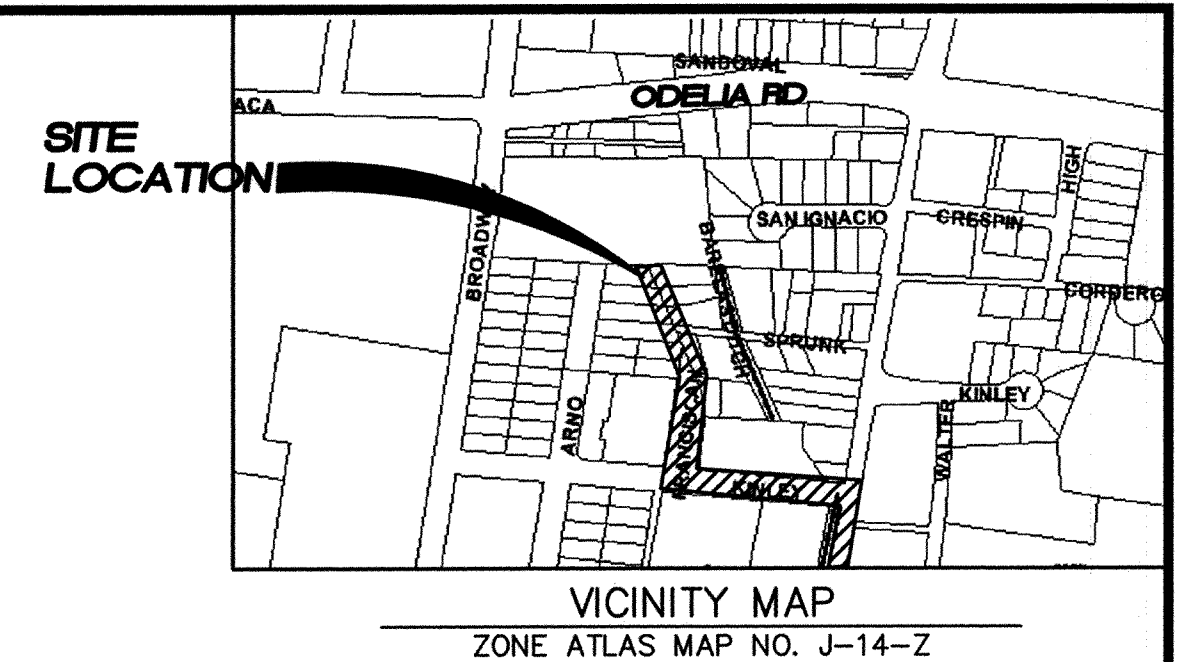

☒ ALL STORM DRAINAGE FACILITIES SHALL BE COMPLETED PRIOR TO FINAL ACCEPTANCE. RCP PIPE JOINTS SHALL NOT BE GROUTED PRIOR TO FINAL INSPECTION. FINAL INSPECTION WILL DETERMINE JOINTS TO BE GROUTED FOR FINAL ACCEPTANCE OF CONSTRUCTION.

RECORD DRAWING
DATE 8-08

[illegible]

WILSON
& COMPANY
4900 LANG AVE. N.E.
ALBUQUERQUE, NEW MEXICO
87109
(505) 348-4000
FAX (505) 348-4072
www.wilsonco.com

WCEA FILE NO. 0660012300

1. THE CONTRACTOR SHALL NOTIFY THE ALBUQUERQUE TRAFFIC ENGINEERING DIVISION THREE (3) WORKING DAYS IN ADVANCE OF ANY WORK REQUIRED REGARDING ALL EXISTING REGULATORY SIGNS AND SIGNALS THAT NEED TO BE REMOVED, RELOCATED, OR REINSTALLED. CALL 857-8680. REFER TO SECTION 18.4.4 OF THE SPECIFICATIONS.

3. THE CONTRACTOR SHALL PROVIDE AND MAINTAIN A SAFE AND ADEQUATE MEANS OF CHANNELING PEDESTRIAN TRAFFIC AROUND ALL WORK AREAS THROUGHOUT THE CONSTRUCTION PERIOD.

5. CONTRACTOR TO CAREFULLY FIELD REVIEW SITE TO ASSESS EXTENT OF TRASH & DEMOLITION REMOVAL. TRASH IS DEFINED AS DEMOLITION TREES, SHRUBS, VEGETATION, ASPHALT, CONCRETE, ABANDONED WET & DRY UTILITIES, MISCELLANEOUS LANDSCAPE, AND CONCRETE CURB & GUTTER TRASH REMOVAL SHALL BE INCLUDED IN BID ITEM "CLEARING & GRUBBING".

7. UNLESS OTHERWISE SHOWN, ALL DIMENSIONS ARE TO FACE OF CURB, INCLUDING RADII OF CURB RETURNS.

9. CURB AND GUTTER SHOWN AS EXISTING AND NOT TO BE REMOVED UNDER THIS CONTRACT WHICH IS DAMAGED OR DISPLACED BY THE CONTRACTOR SHALL BE REMOVED AND REPLACED PER STD DWG 2415 BY THE CONTRACTOR AT HIS EXPENSE.

11. WHEN ABUTTING NEW PAVEMENT TO EXISTING PAVEMENT, SAW CUT EXISTING PAVEMENT IN A STRAIGHT LINE AS REQUIRED TO REMOVE ANY BROKEN OR CRACKED PAVEMENT. PRIOR TO LAYING NEW PAVEMENT, THE EXPOSED EXISTING ASPHALT EDGE SHALL BE CLEAN AND TACK-COATED.

13. ALL WHEELCHAIR RAMP APPROACH SLOPES SHOWN ON STD DWG 2441 SHALL BE INCREASED IN LENGTH TO MAINTAIN 12:1 MAX SLOPE WHEN GRADE IS RISING FROM RAMP. SEE TABLE BELOW.

RISE	GRADE	RAMP LENGTH
0%		8.1'
0-1%		9.2'
1-2%		10.6'
2-3%		12.6'
3-4%		15.5'

15. ALL EXISTING UTILITIES SHOWN HEREIN WERE TAKEN FROM RECORD DRAWINGS, POTHOLE, FIELD SURVEYS, C.O.A. SYSTEMS UTILITIES MAPS AND INFORMATION PROVIDED BY THE UTILITY OWNERS AND ARE APPROXIMATE. IT WILL BE THE CONTRACTOR'S RESPONSIBILITY TO FIELD VERIFY THEIR HORIZONTAL AND VERTICAL LOCATIONS AND PROVIDE PROTECTION FOR ALL UTILITIES WITHIN THE CONSTRUCTION AREA.

17. MANHOLE RIM ELEVATIONS SHOWN ON THESE PLANS ARE APPROXIMATE AND WILL VARY WITH THE FINISHED PAVEMENT ELEVATIONS.

18. CONTRACTOR TO VERIFY ALL EXISTING FIRE HYDRANT FLANGES, PADS, VALVE BOXES, MANHOLE RIMS AND TOP OF PIPE ELEVATIONS IN THE FIELD. ELEVATIONS SHALL BE ADJUSTED TO COMPLY WITH THE REQUIREMENTS OF STANDARD CITY DETAILS.

20. ALL WATER VALVE BOXES AND SEWER MANHOLES IN THE CONSTRUCTION AREA ARE TO BE ADJUSTED TO FINISH GRADE UNDER THIS CONTRACT, AND WILL BE PAID FOR AT CONTRACT UNIT PRICES.

21. THE CONTRACTOR SHALL NOTIFY THE LOCAL FIRE DEPARTMENT AT LEAST TWO (2) WORKING DAYS IN ADVANCE OF WHEN FIRE HYDRANTS WILL BE TAKEN OUT OF SERVICE AND RETURNED TO SERVICE.

22. ALL WATER SERVICES LISTED AS "DOUBLE" REFER TO DOUBLE METER BOX. A SEPARATE SERVICE LINE TO EACH METER IS REQUIRED. REFERENCE C.O.A. STD. DRAWINGS 2361, 2362.

23. ALL EXISTING GAS VALVE BOXES, GAS MANHOLES, ELECTRICAL MANHOLES, AND TELEPHONE MANHOLES WILL BE ADJUSTED TO GRADE BY OTHERS.

24. WHERE PULL BOXES ABUT BACK OF CURB OR ARE LOCATED IN A CONCRETE PAVED AREA, PROVIDE 3/4" EXPANSION MATERIAL AROUND THE PULL BOX. ALL PULL BOXES TO BE FLUSH WITH SURFACE OF CONCRETE.

25. THE CONTRACTOR SHALL MEET ALL THE REQUIREMENTS OF THE NATIONAL POLLUTANT DISCHARGE ELIMINATION SYSTEM (NPDES) AS WELL AS LOCAL REGULATIONS.

26. THE CONTRACTOR SHALL COORDINATE WITH PRIVATE UTILITY ENTITIES AS NEEDED FOR RELOCATION AND INSTALLATION OF PRIVATE UTILITIES. ENGINEER HAS NOTIFIED THE PRIVATE UTILITIES OF THIS PROJECT.

27. TEMPORARY EROSION FENCING (OR PERMANENT WALLS OR FENCING) SHALL BE USED TO PROTECT EXISTING RESIDENTIAL PROPERTY, STREETS LANDSCAPING AND THE DRAINAGE SYSTEMS FROM THE DEPOSITION OF ERODED MATERIAL.



28. CONSTRUCTION AREA SHALL BE CONTROLLED TO PREVENT TRESPASS USE BY 4WD'S, ORV'S AND MOTORCYCLES TO MINIMIZE NOISE, DUST, DESTRUCTION OF VEGETATION, WIND AND WATER EROSION.

29. CONTRACTOR SHALL LOCATE EXISTING IRRIGATION LINE(S) AND CUT & CAP SERVICE 5'-0" OUTSIDE OF CONSTRUCTION LIMITS. COST IS INCIDENTAL TO BID ITEM "CLEARING AND GRUBBING".


30. THE CONTRACTOR SHALL MAINTAIN AN UP TO DATE SET OF AS-BUILT PLANS FOR THE PROJECT. THESE PLANS SHALL BE KEPT CURRENT, WITHIN TWO WEEKS AT ALL TIMES AND SHALL BE SUBJECT TO REVIEW BY THE PROJECT ENGINEER FOR ACCURACY AND COMPLETENESS AT LEAST ONCE EVERY 14 CALENDAR DAYS. THE FINAL AS-BUILT PLANS SHALL BE SUBMITTED TO THE PROJECT ENGINEER PRIOR TO FINAL PAYMENT. AS-BUILTS SHALL BE CERTIFIED, SIGNED AND DATED BY THE CONTRACTOR FOR COMPLETENESS AND ACCURACY OF INFORMATION.

COMPANY	PHONE	MOBILE	CONTACT
ABCWUA	768-2729		NANCY MUSINSKI
PNM – ELECTRIC	241-3398		ART CHAVEZ
PNM – GAS	241-7771		JOE DUNLOP
QWEST	245-6374		ROSA KNIFFIN
COMCAST	761-6221		ROBERT MARTINEZ

	4900 LANG AVENUE NE ALBUQUERQUE, NEW MEXICO 87109 (505) 348-4000 FAX (505) 348-4072		<table border="1"> <tr><td></td><td></td><td></td><td></td><td></td><td></td></tr> <tr><td></td><td></td><td></td><td></td><td></td><td></td></tr> <tr><td></td><td></td><td></td><td></td><td></td><td></td></tr> <tr><td></td><td></td><td></td><td></td><td></td><td></td></tr> </table>																										NO. DA	DESIGNED	DRAWN BY	CHECKED BY
 CITY OF ALBUQUERQUE DEPARTMENT OF MUNICIPAL DEVELOPMENT STORM DRAIN DIVISION																																
TITLE: FLOOD CONTROL ON-CALL CONTRACT																																
GENERAL NOTES																																
Design Review Committee		City Engineer Approval		Last Design Update	Mo./Day/Yr.		Mo./Day/Yr.																									
City Project No.		Zone Map No.		Sheet		Of																										
7963.05		J-14-Z		2		7																										

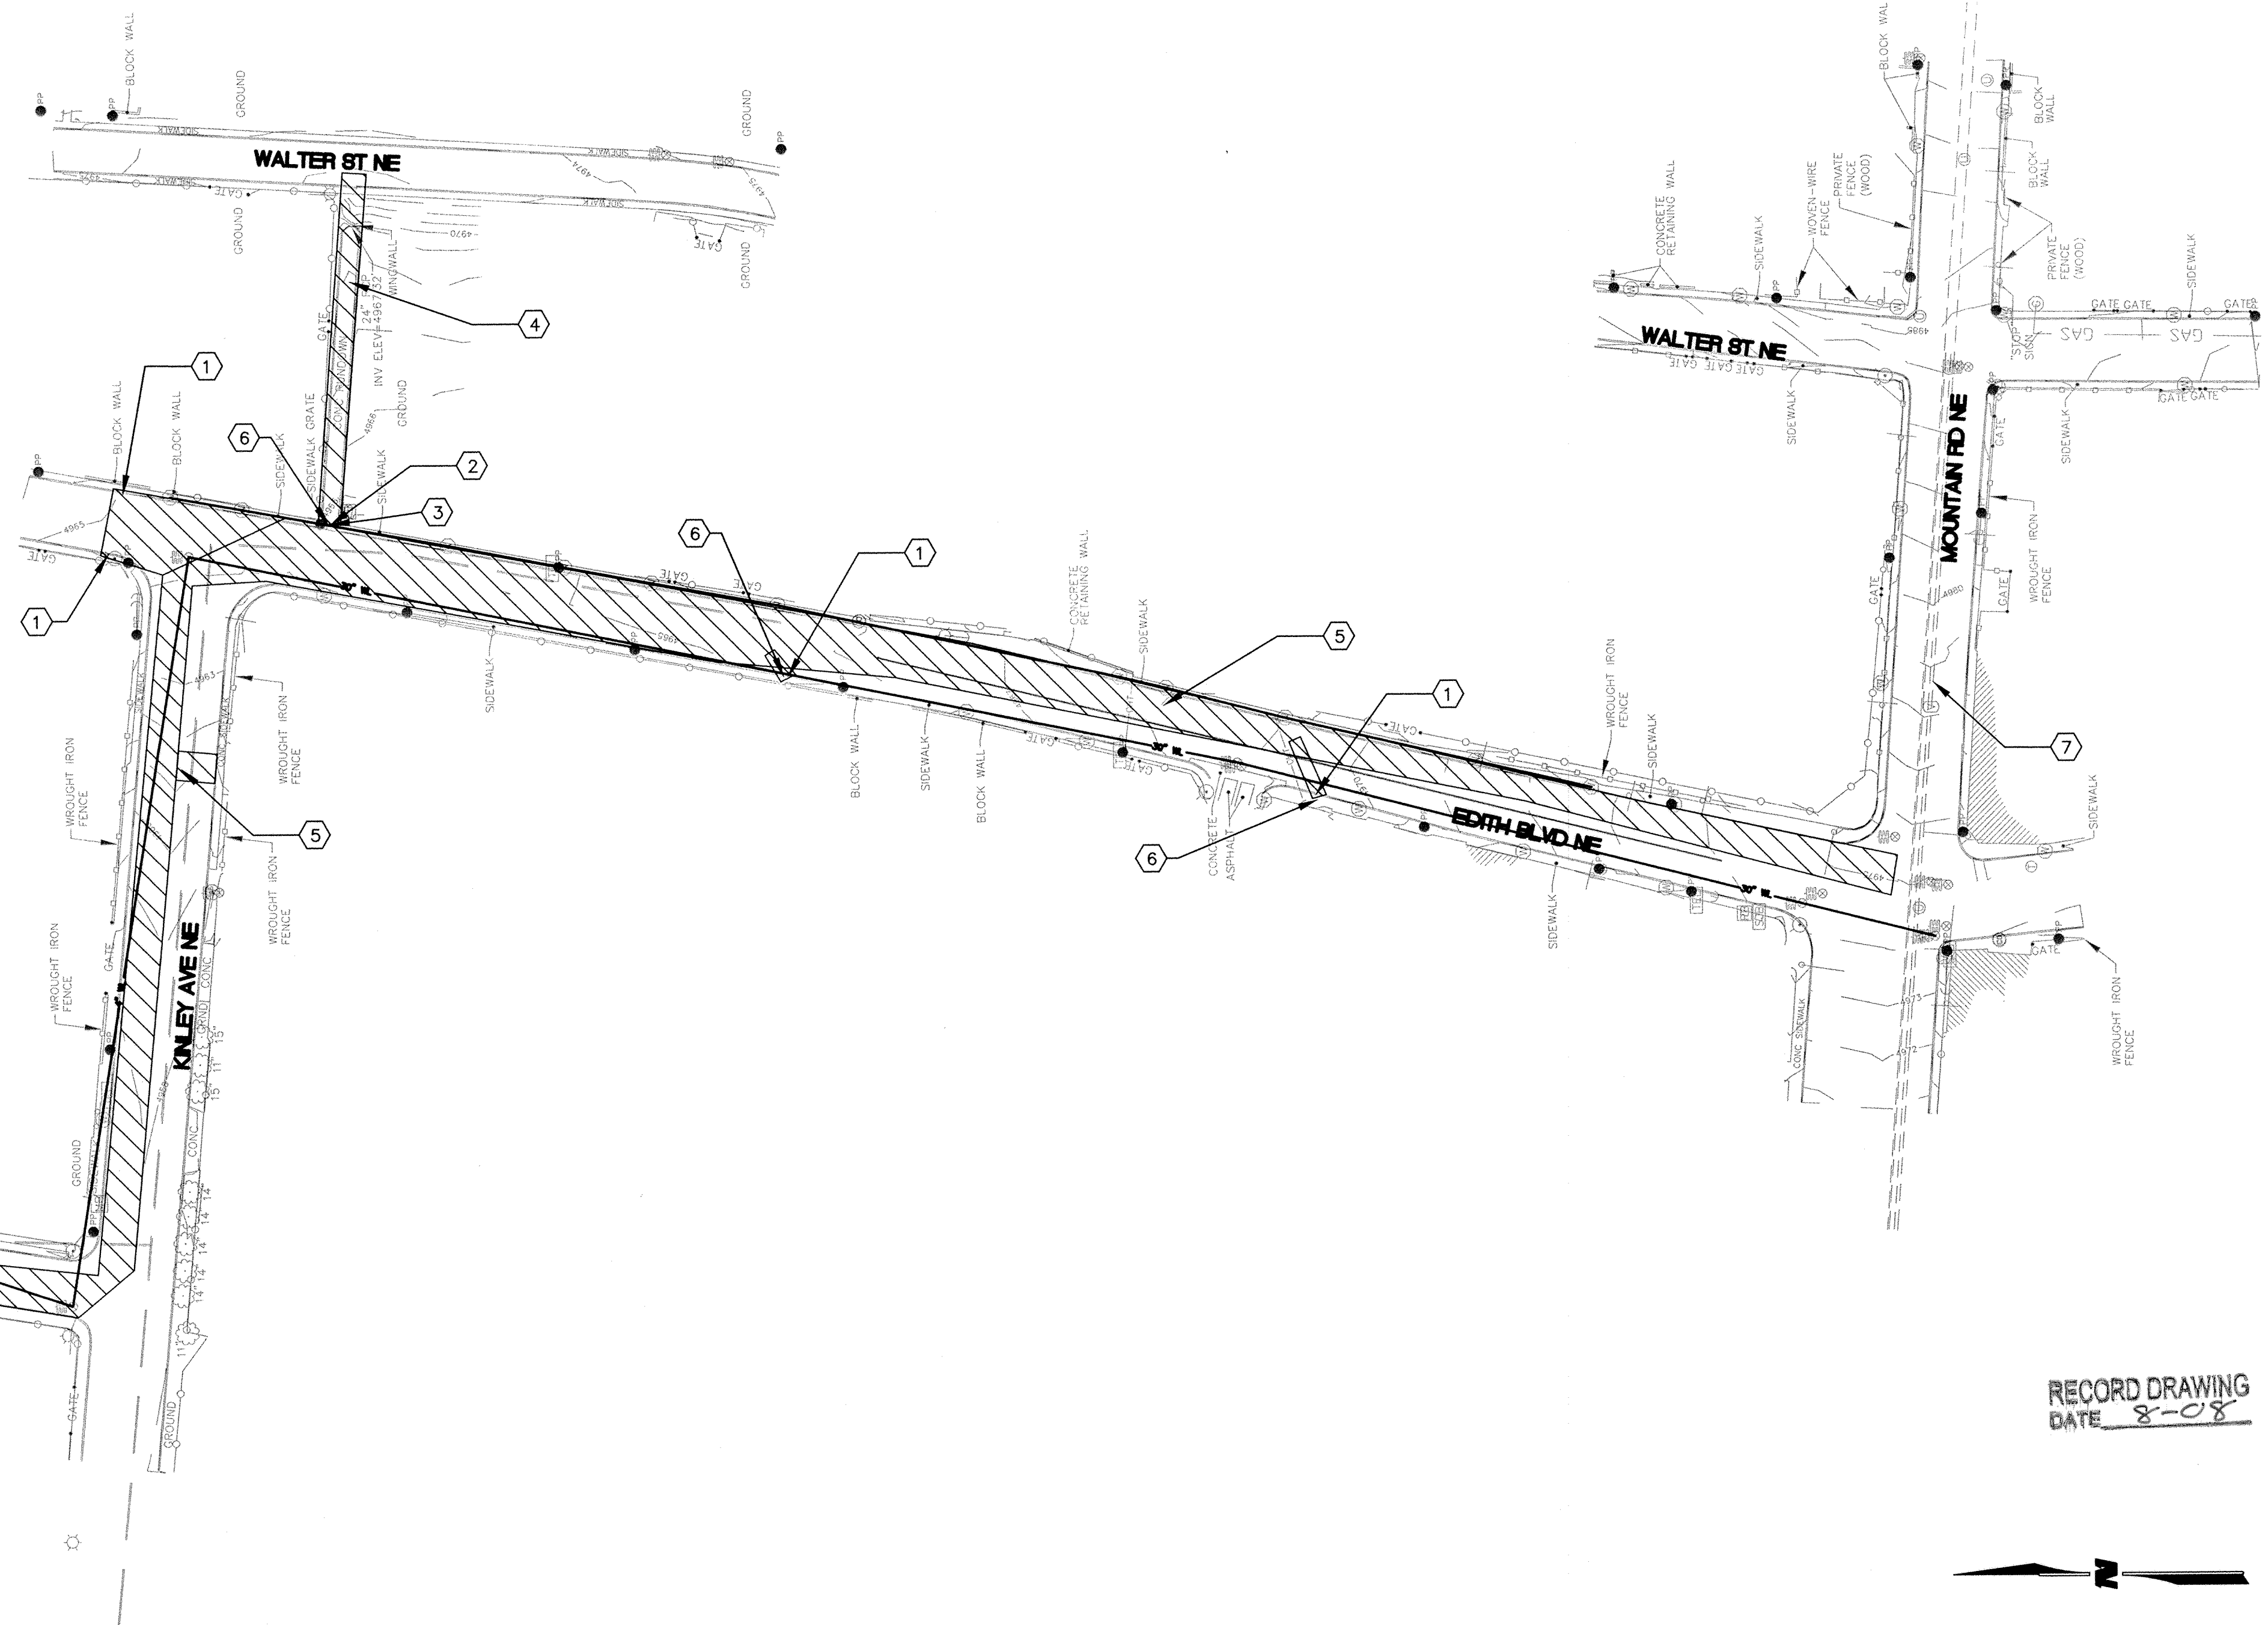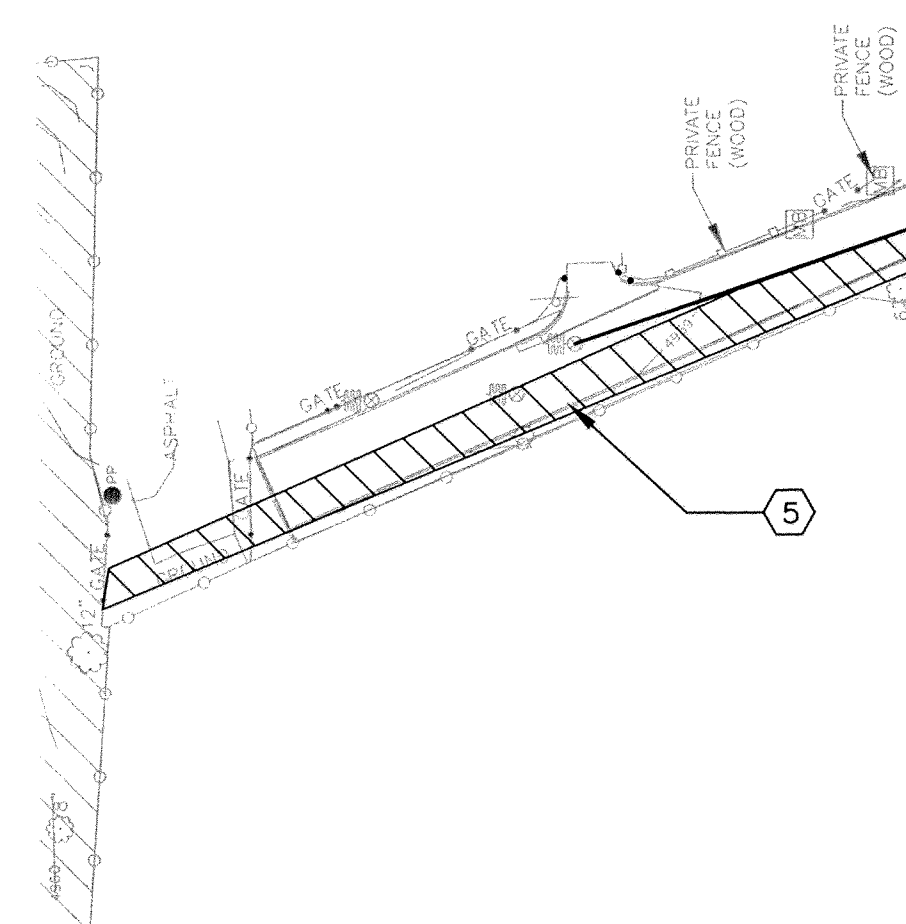

RECORD DRAWING
DATE 8-08

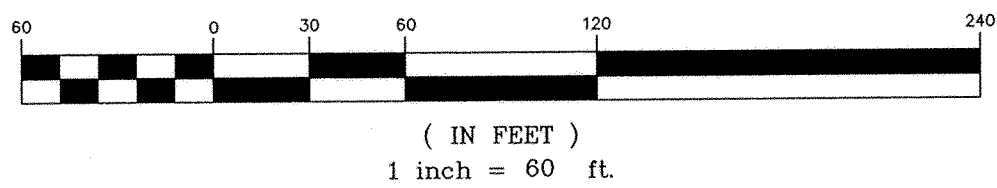**WILSON**
& COMPANY

4900 LANG AVENUE NE
ALBUQUERQUE, NEW MEXICO
87109
(505) 348-4000
FAX (505) 348-4072




CITY OF ALBUQUERQUE
DEPARTMENT OF MUNICIPAL DEVELOPMENT
STORM DRAIN DIVISION

TITLE: **FLOOD CONTROL ON-CALL CONTRACT**
DEMOLITION PLAN

Design Review Committee	City Engineer Approval	Last Design Update	Mo./Day/Yr.	Mo./Day/Yr.
City Project No. 7963.05		Zone Map No. J-14-N	Sheet 3	Of 7


T:\Projects\0660012300\CADD\SHEETS\SHEETS KINLEY\PNP\6123PNP08_KINLEY.dwg 1/30/2008 8:39:00 AM NST

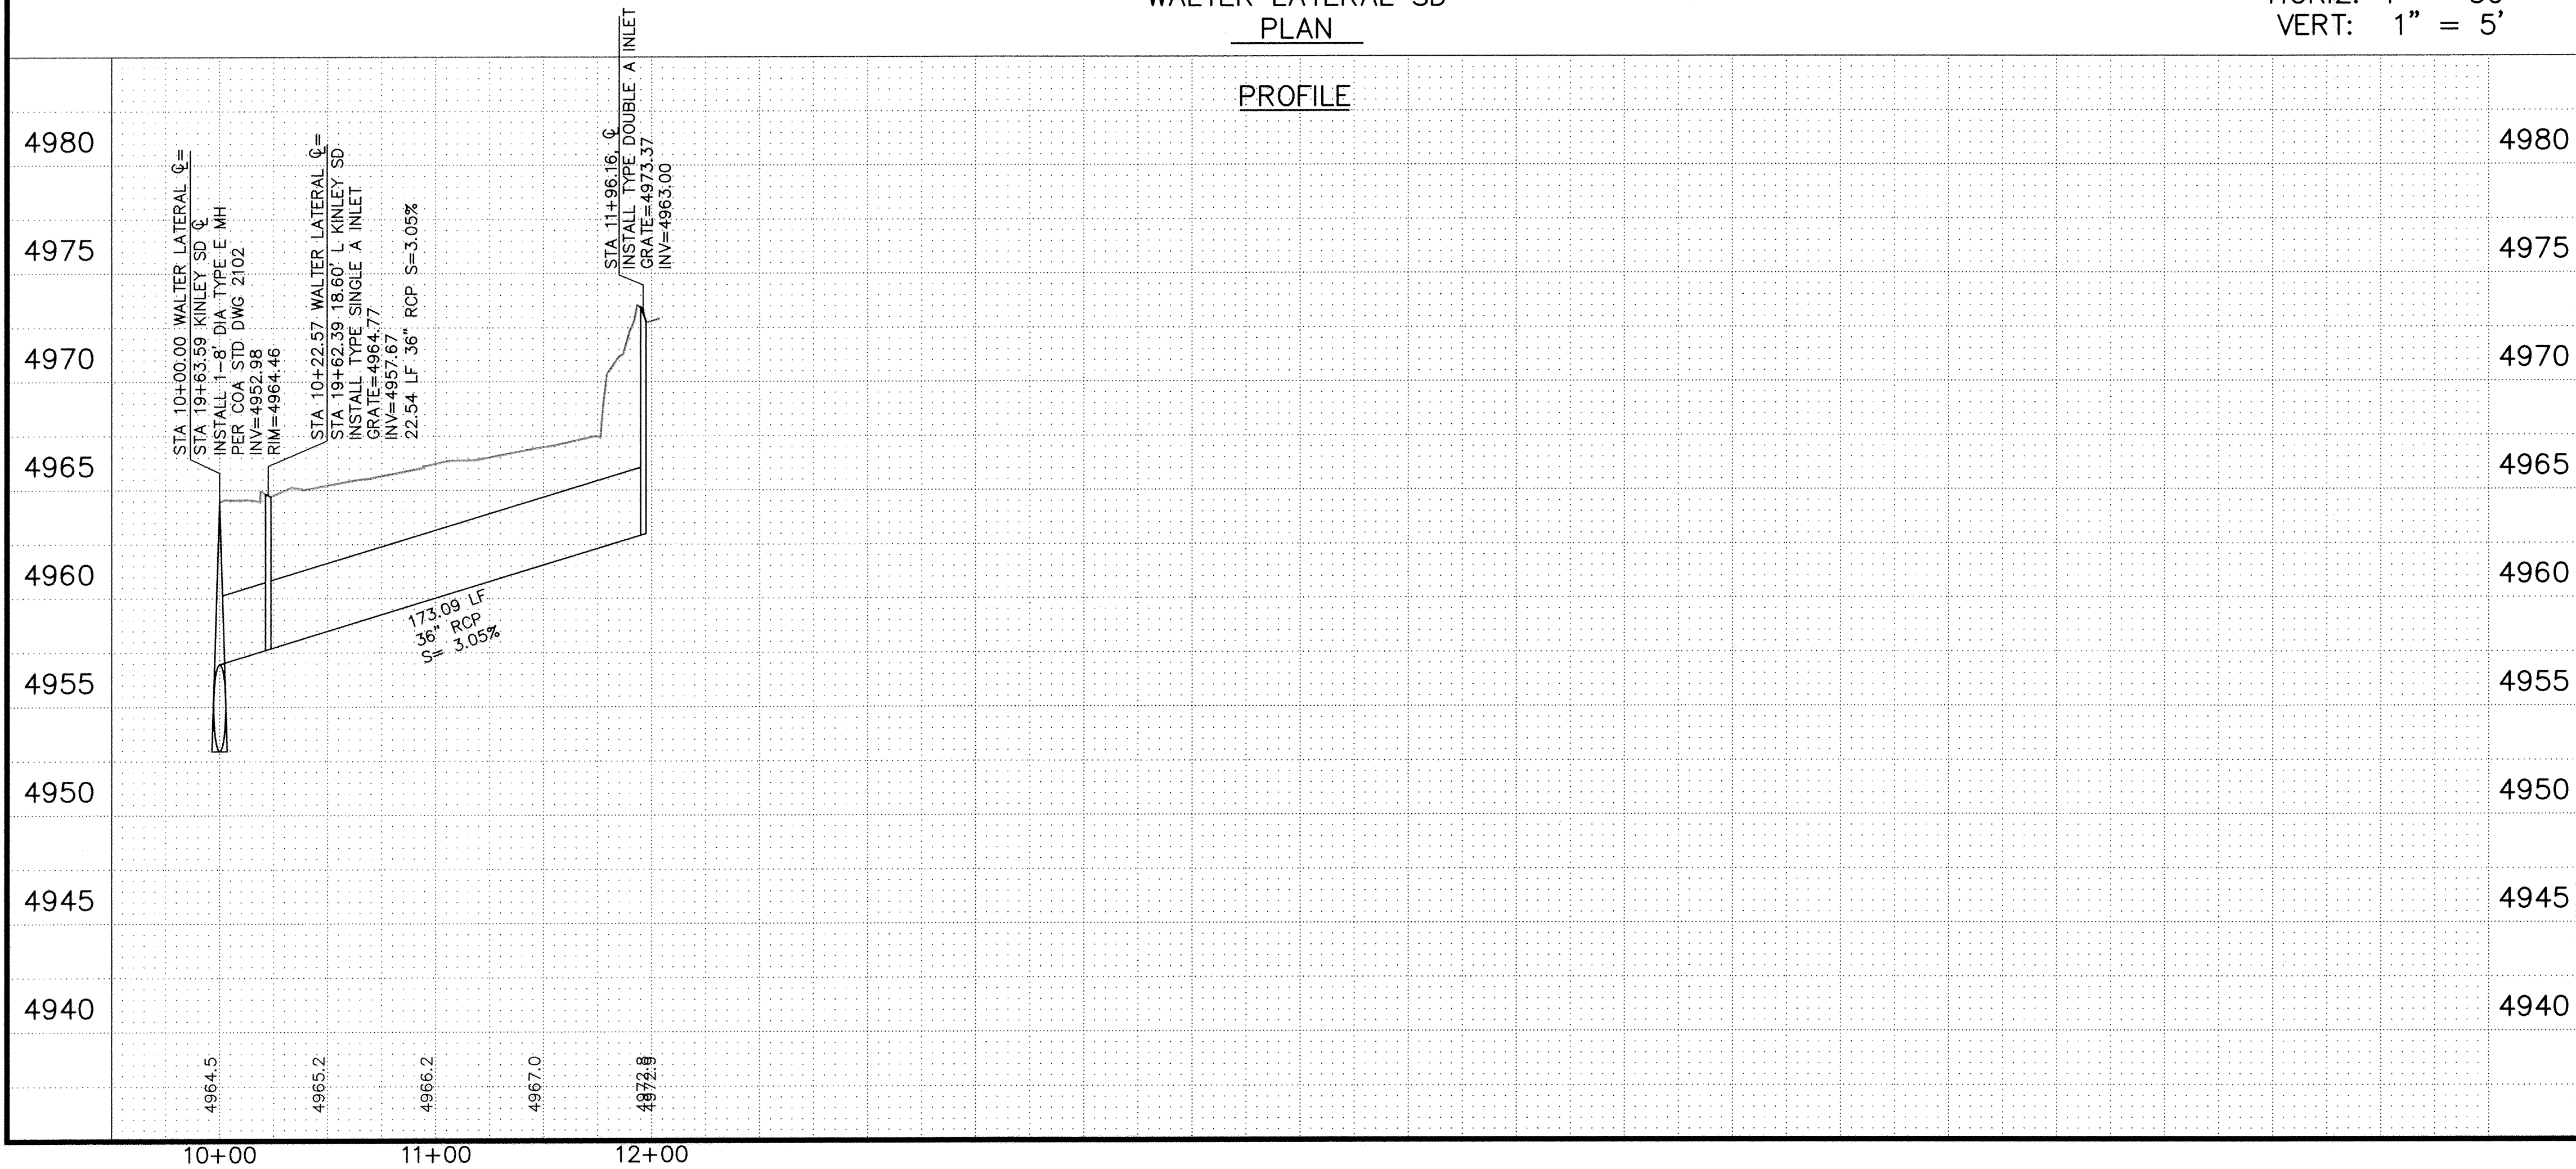

RECORD DRAWING
DATE 8-08



SCALE:
HORIZ: 1" = 50'
VERT: 1" = 5'

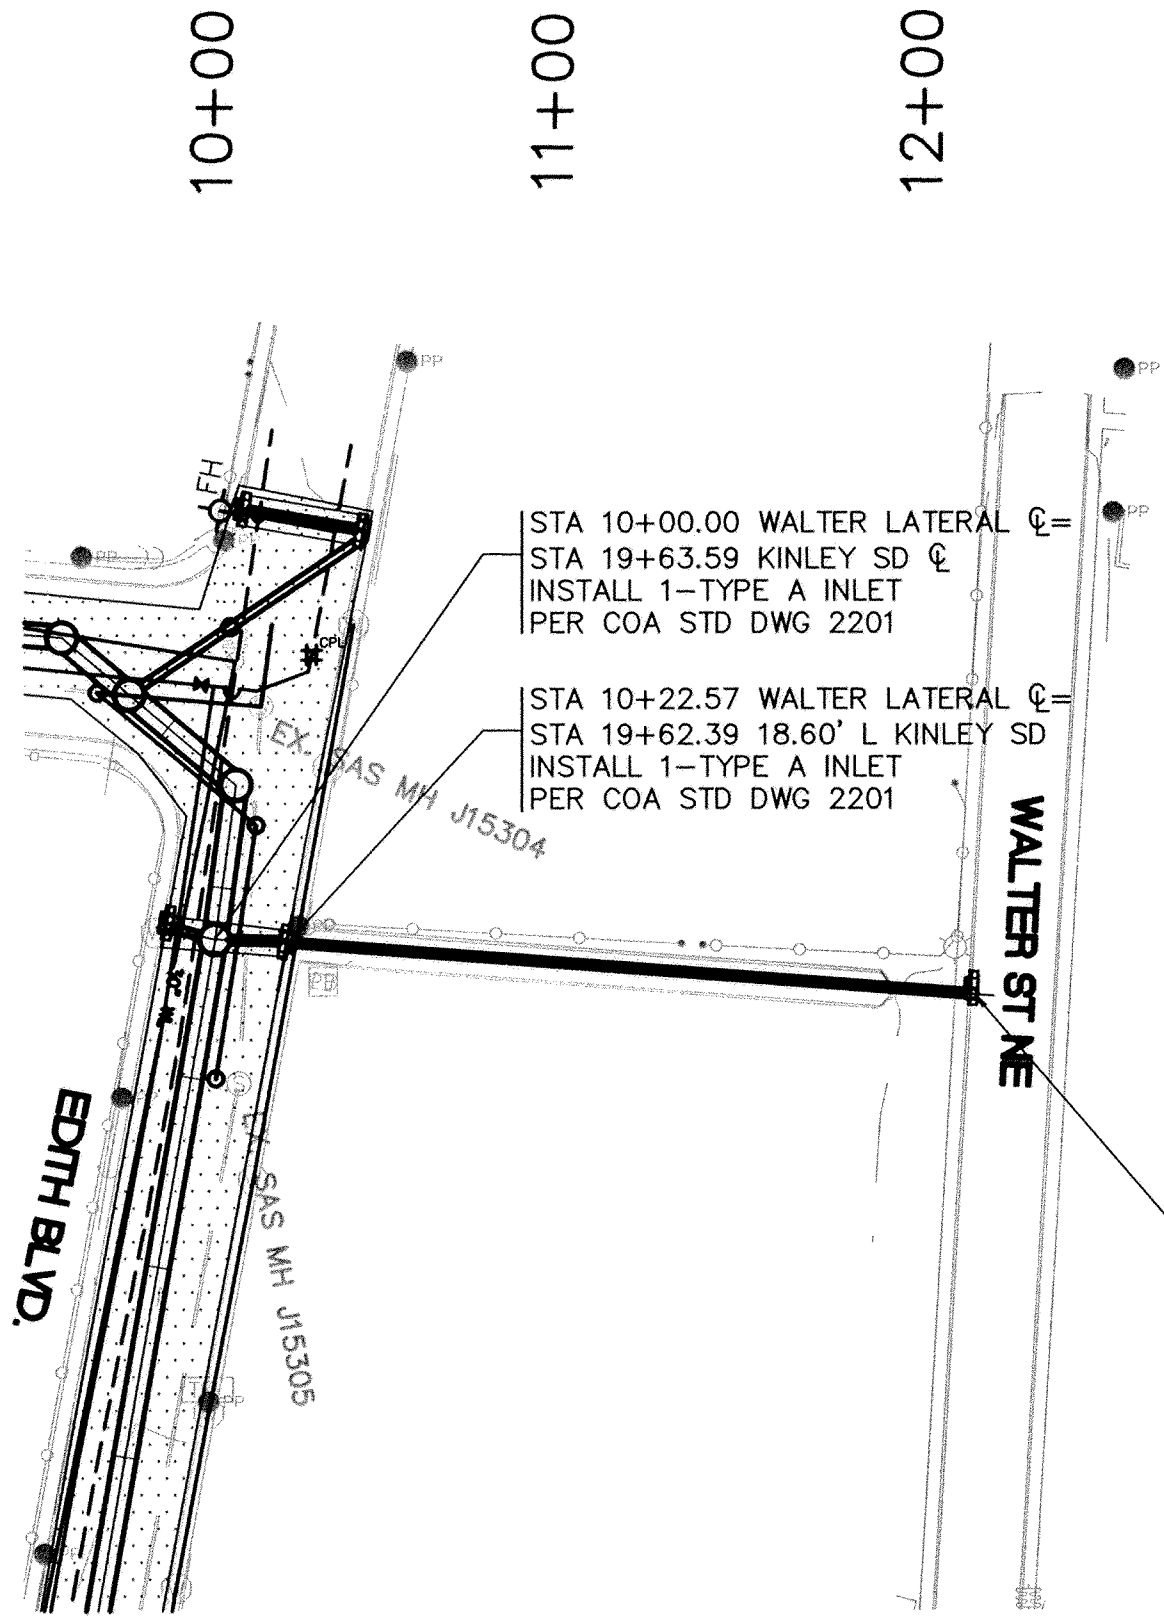

LEGEND

- PAVED ROAD
- UNPAVED ROAD
- TRAIL
- FENCE
- BUILDING
- LIGHT POLE
- UTILITY POLES
- GUY WIRE
- TREE
- TREE
- TREE
- TREE & BRUSH LINE
- MANHOLE
- FIRE HYDRANT
- VAULT
- BLOW-OFF VALVE
- WATER VALVE
- WATER METER
- FIRE HYDRANT
- SPRINKLER CONTROL BOX
- ELECTRICAL, PULL BOX
- ELECTRICAL, JUNCTION BOX
- UTILITY, SANITARY MANHOLE
- UTILITY, STORM DRAINAGE MANHOLE
- UTILITY, UNKNOWN MANHOLE
- TV PEDESTAL
- TELEPHONE PEDESTAL
- PROPERTY CORNER, EXISTING
- TRAFFIC SIGNAL
- WATER LINE, UNDERGROUND
- GAS LINE, UNDERGROUND
- TELEVISION LINE, UNDERGROUND
- ELECTRIC LINE, UNDERGROUND
- AREA OF DEMOLITION
- PROPOSED CONCRETE
- PROPOSED RETAINING WALL
- PROPOSED RIDGE LINE

WILSON
& COMPANY

2600 THE AMERICAN ROAD S.E.
SUITE 100
RIO RANCHO, NEW MEXICO
87124
(505) 898-8021



CITY OF ALBUQUERQUE
DEPARTMENT MUNICIPAL DEVELOPMENT
STORM DRAIN DIVISION

TITLE: FLOOD CONTROL ON-CALL CONTRACT
WALTER LATERAL PLAN & PROFILE
STA 10+00 TO 11+96.16

Design Review Committee

City Engineer Approval

Last Design Update

Mo./Day/Yr.

Mo./Day/Yr.


City Project No. 7963.05

Zone Map No. J-14-Z

Sheet

6

Of 7

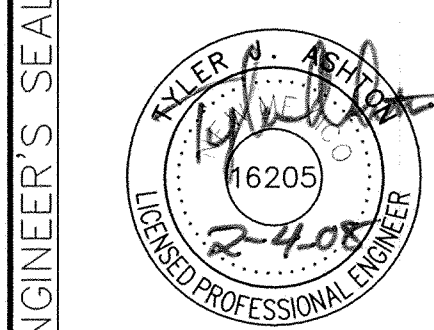

ENGINEER'S SEAL

NO. DATE

BY

REVISIONS

DESIGN

DATE: JUN 2007

DATE: JUN 2007

DATE: JUN 2007

DESIGNED BY: TJA

DRAWN BY: JLL

CHECKED BY: MJJ

Diagram illustrating the cross-section of a road structure, showing the following layers and specifications:

- 1-3" LIFT SP-III PAVEMENT COURSE (SECTION 116,336).
- TACK COAT AS REQUIRED BY THE ENGINEER.
- 1-3" LIFT SP-III PAVEMENT COURSES (SECTION 116,336).
- 12" SCARIFIED AND COMPACTED SUBGRADE R-VALUE>50 95% MIN. PER COA SECTION 301
- SEE SECTIONS 202,204 AND 301 FOR CUT, FILL, AND SUBGRADE CONSTRUCTION REQUIREMENTS

1-3" LIFT SP-III PAVEMENT COURSE
(SECTION 116,336).

TACK COAT AS REQUIRED BY THE ENGINEER.


1-6" LIFT SP-III PAVEMENT COURSES
(SECTION 116,336).

12" SCARIFIED AND
COMPACTED SUBGRADE R-VALUE>50
95% MIN. PER COA SECTION 301


SEE SECTIONS 202,204 AND 301
FOR CUT, FILL, AND SUBGRADE
CONSTRUCTION REQUIREMENTS.

		4900 LANG AVENUE NE ALBUQUERQUE, NEW MEXICO 87109 (505) 348-4000 FAX (505) 348-4072		NO. DA DESIGNED BY DRAWN BY CHECKED BY		
		CITY OF ALBUQUERQUE DEPARTMENT OF MUNICIPAL DEVELOPMENT STORM DRAIN DIVISION				
		TITLE: FLOOD CONTROL ON-CALL CONTRACT				
Design Review Committee		City Engineer Approval		Last Design Update		Mo./Day/Yr.
						Mo./Day/Yr.
						Mo./Day/Yr.
						Mo./Day/Yr.
						Mo./Day/Yr.
						Mo./Day/Yr.
City Project No. 7963.05		Zone Map No. J-14-Z		Sheet 7 Of 7		



- KEY NOTES**
- 1 NEW FIRE HYDRANT
 - 2 105 LF OF NEW 6" C900 WATERLINE
 - 3 NEW 4'-0" DIA. SAS MH
 - 4 115 LF OF EXISTING 6" SAS REMOVED. 115 LF OF NEW 8" SDR-35 STA 10+97.60 TO STA 12+12.60, 6.66' LT
 - 5 1-NEW 6" TRANSITION COUPLING 1-NON PRESSURE CONNECTION
 - 6 NEW 6" GATE VALVE
 - 7 EXISTING 6" AC
 - 8 EXISTING 6" SAS
 - 9 122 LF OF NEW 6" C900 WATERLINE
 - 10 22 LF OF NEW 6" C900 WATERLINE
 - 11 459 LF OF EXISTING 4" C.I. WATER LINE REMOVED STA 11+07.37 TO STA 15+66.37, 13.40' LT
 - 12 176 LF OF NEW 6" C900 WATERLINE
 - 13 28 LF OF NEW 6" C900 WATERLINE
 - 14 1-NEW 6"x4" REDUCER 1-CONNECTION TO EXISTING 4" C.I.
 - 15 3 LF OF NEW 6" C900 WATERLINE
 - 16 6 LF OF NEW 6" C900 WATERLINE
 - 17 2 LF OF NEW 6" C900 WATERLINE
 - 18 386 LF OF NEW 6" C900 WATERLINE
 - 19 NEW 4'-0" DIA. SAS MH INV=4656.41
 - 20 413 LF OF EXISTING 4" C.I. WATER LINE REMOVED STA 15+35.31 TO STA 19+48.31 30.62' RT
 - 21 1-NEW TRANSITION COUPLING 1-CONNECTION TO EXISTING 6" STEEL PIPE
 - 22 20 LF OF NEW 6" C900 WATERLINE
 - 23 40 LF OF NEW 8" SDR-35 S=0.6%
 - 24 66 LF OF NEW 8" SDR-35 S=0.6%
 - 25 512 LF OF NEW 6" C900 WATERLINE
 - 26 274 LF OF NEW 8" SDR-35 S=0.83%
 - 27 300 LF OF EXISTING 8" SAS REMOVED STA 19+15.07 TO STA 22+15.07 19.73' LT
 - 28 4 LF OF NEW 6" C900 WATERLINE
 - 29 295 LF OF NEW 6" C900 WATERLINE
 - 30 850 LF OF EXISTING 6" C.I. WATER LINE REMOVED STA 19+17.68 TO STA 27+67.68, 37.05' LT
 - 31 EXISTING 30" WATER LINE
 - 32 30 LF OF NEW 6" C900 WATERLINE
 - 33 12 LF OF NEW 6" C900 WATERLINE
 - 34 51 LF OF NEW 6" C900 WATERLINE. REMOVED 51 LF OF EXISTING 6" C.I.
 - 35 1-NEW 6"x4" REDUCER 1-NEW TRANSITION COUPLING, 1-CONNECTION
 - 36 55 LF OF NEW 6" C900 WATERLINE
 - 37 NEW 6" TEE

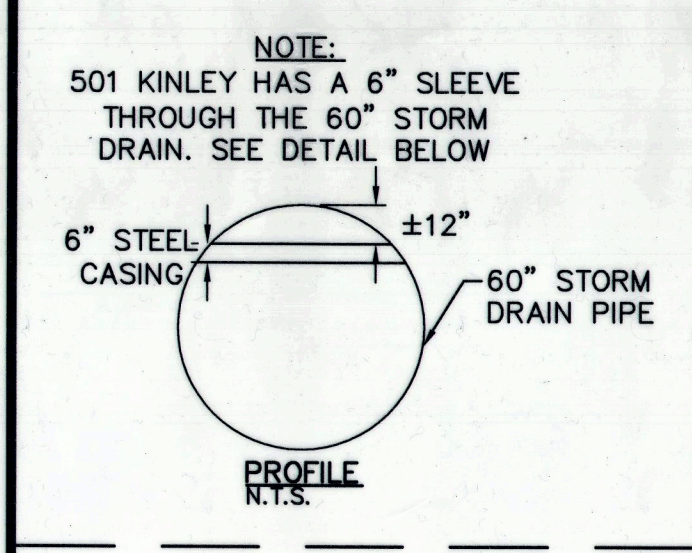

***NOTE:**
ALL STATIONING BASED ON KINLEY STORM DRAIN CENTERLINE.

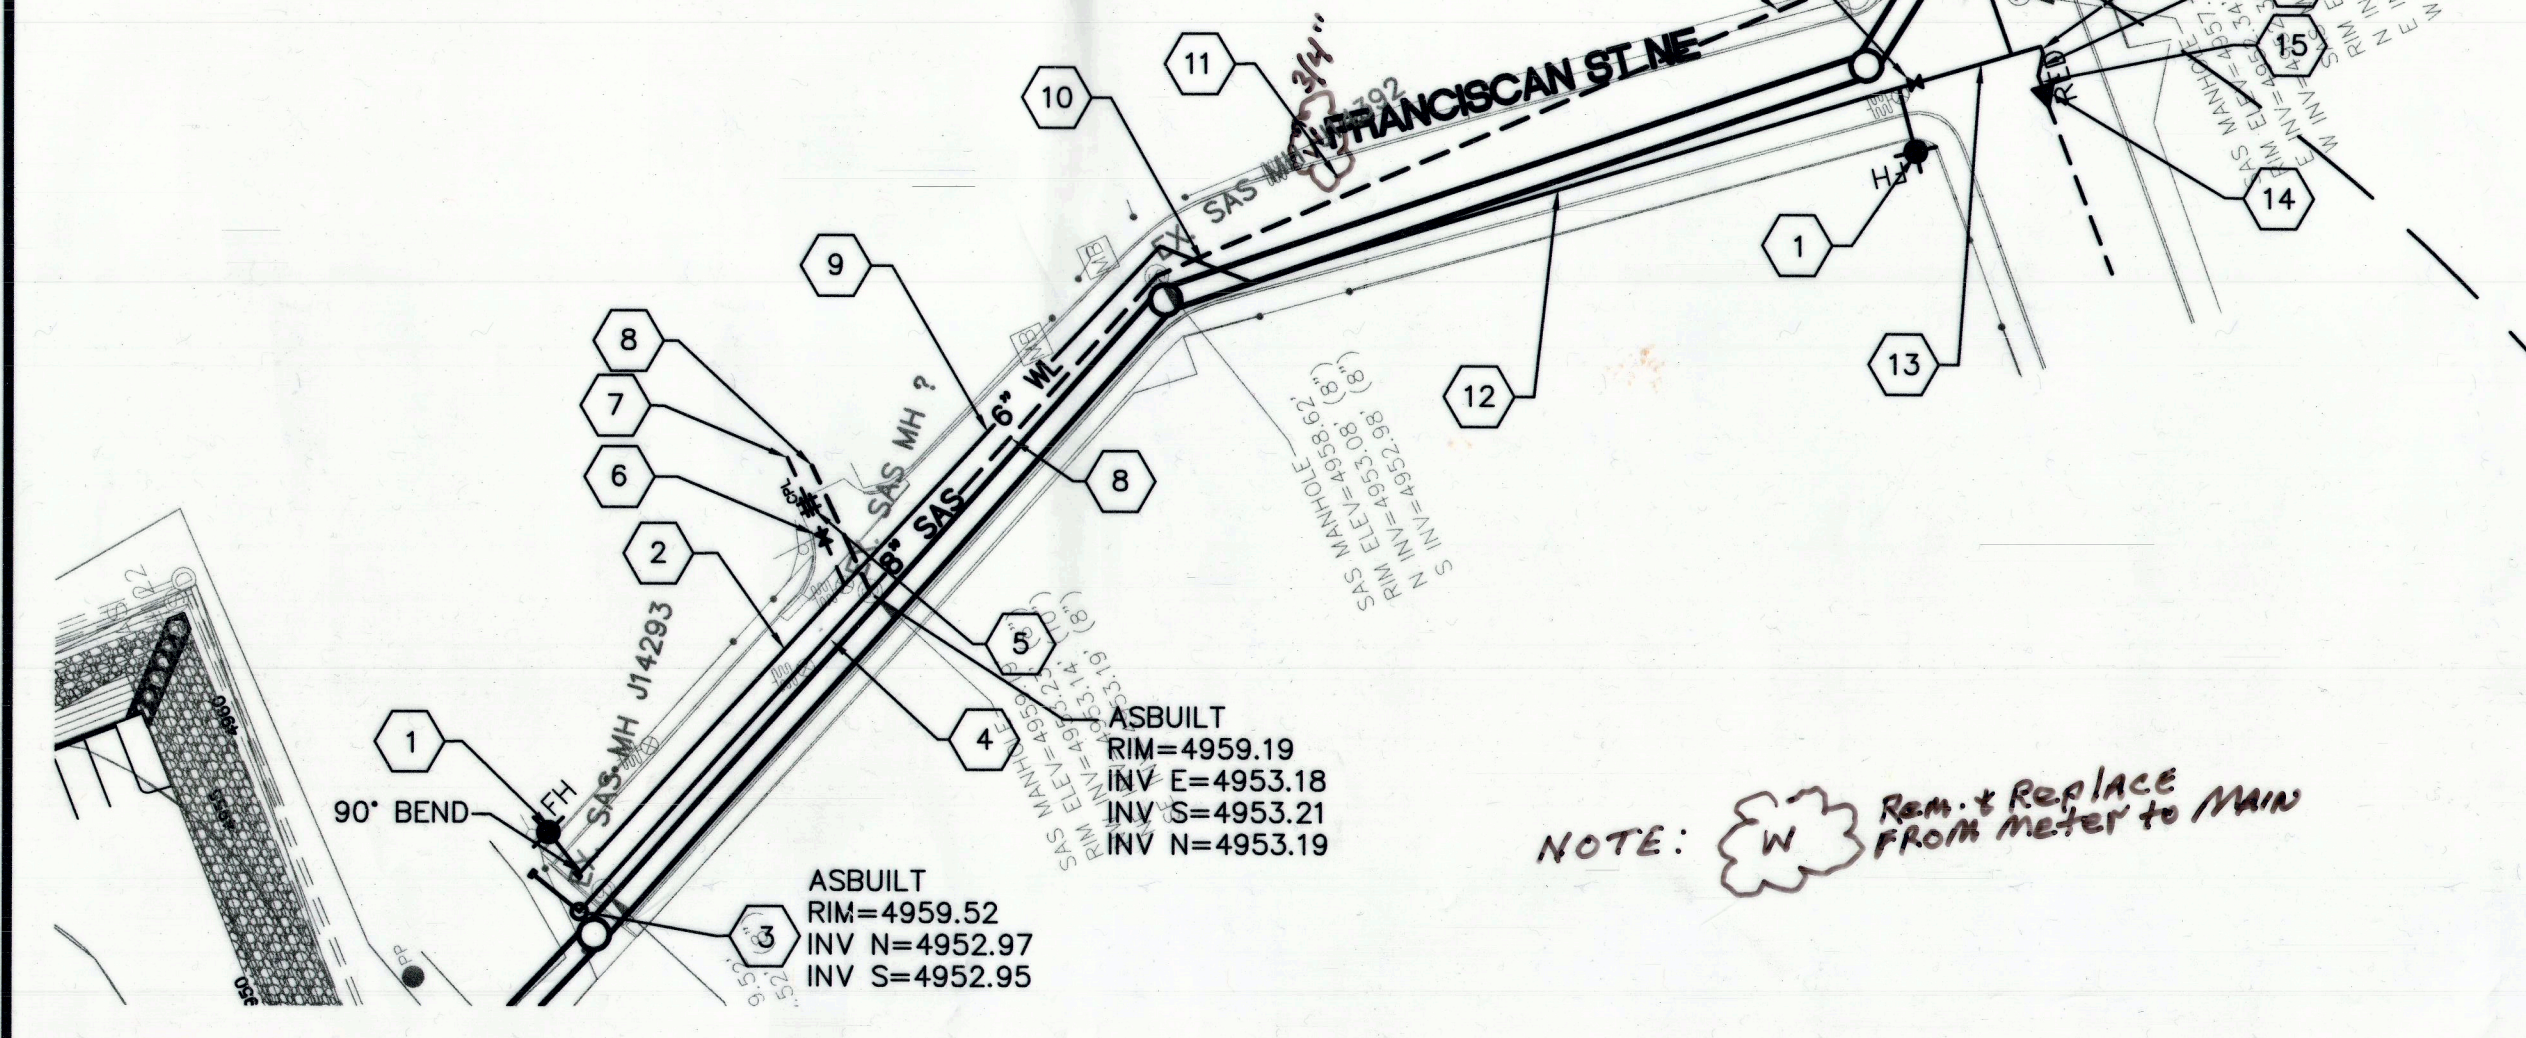

NOTE: W Rem. & Replace FROM Meter to MIN

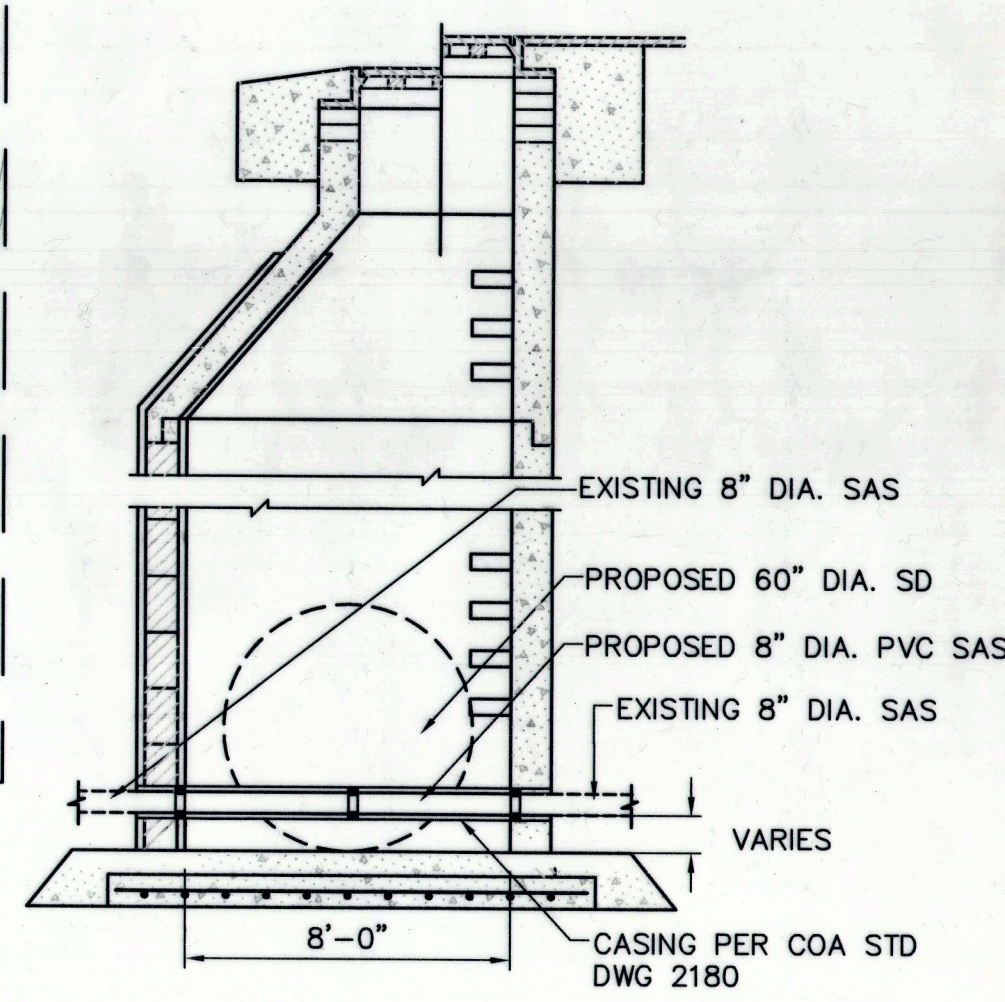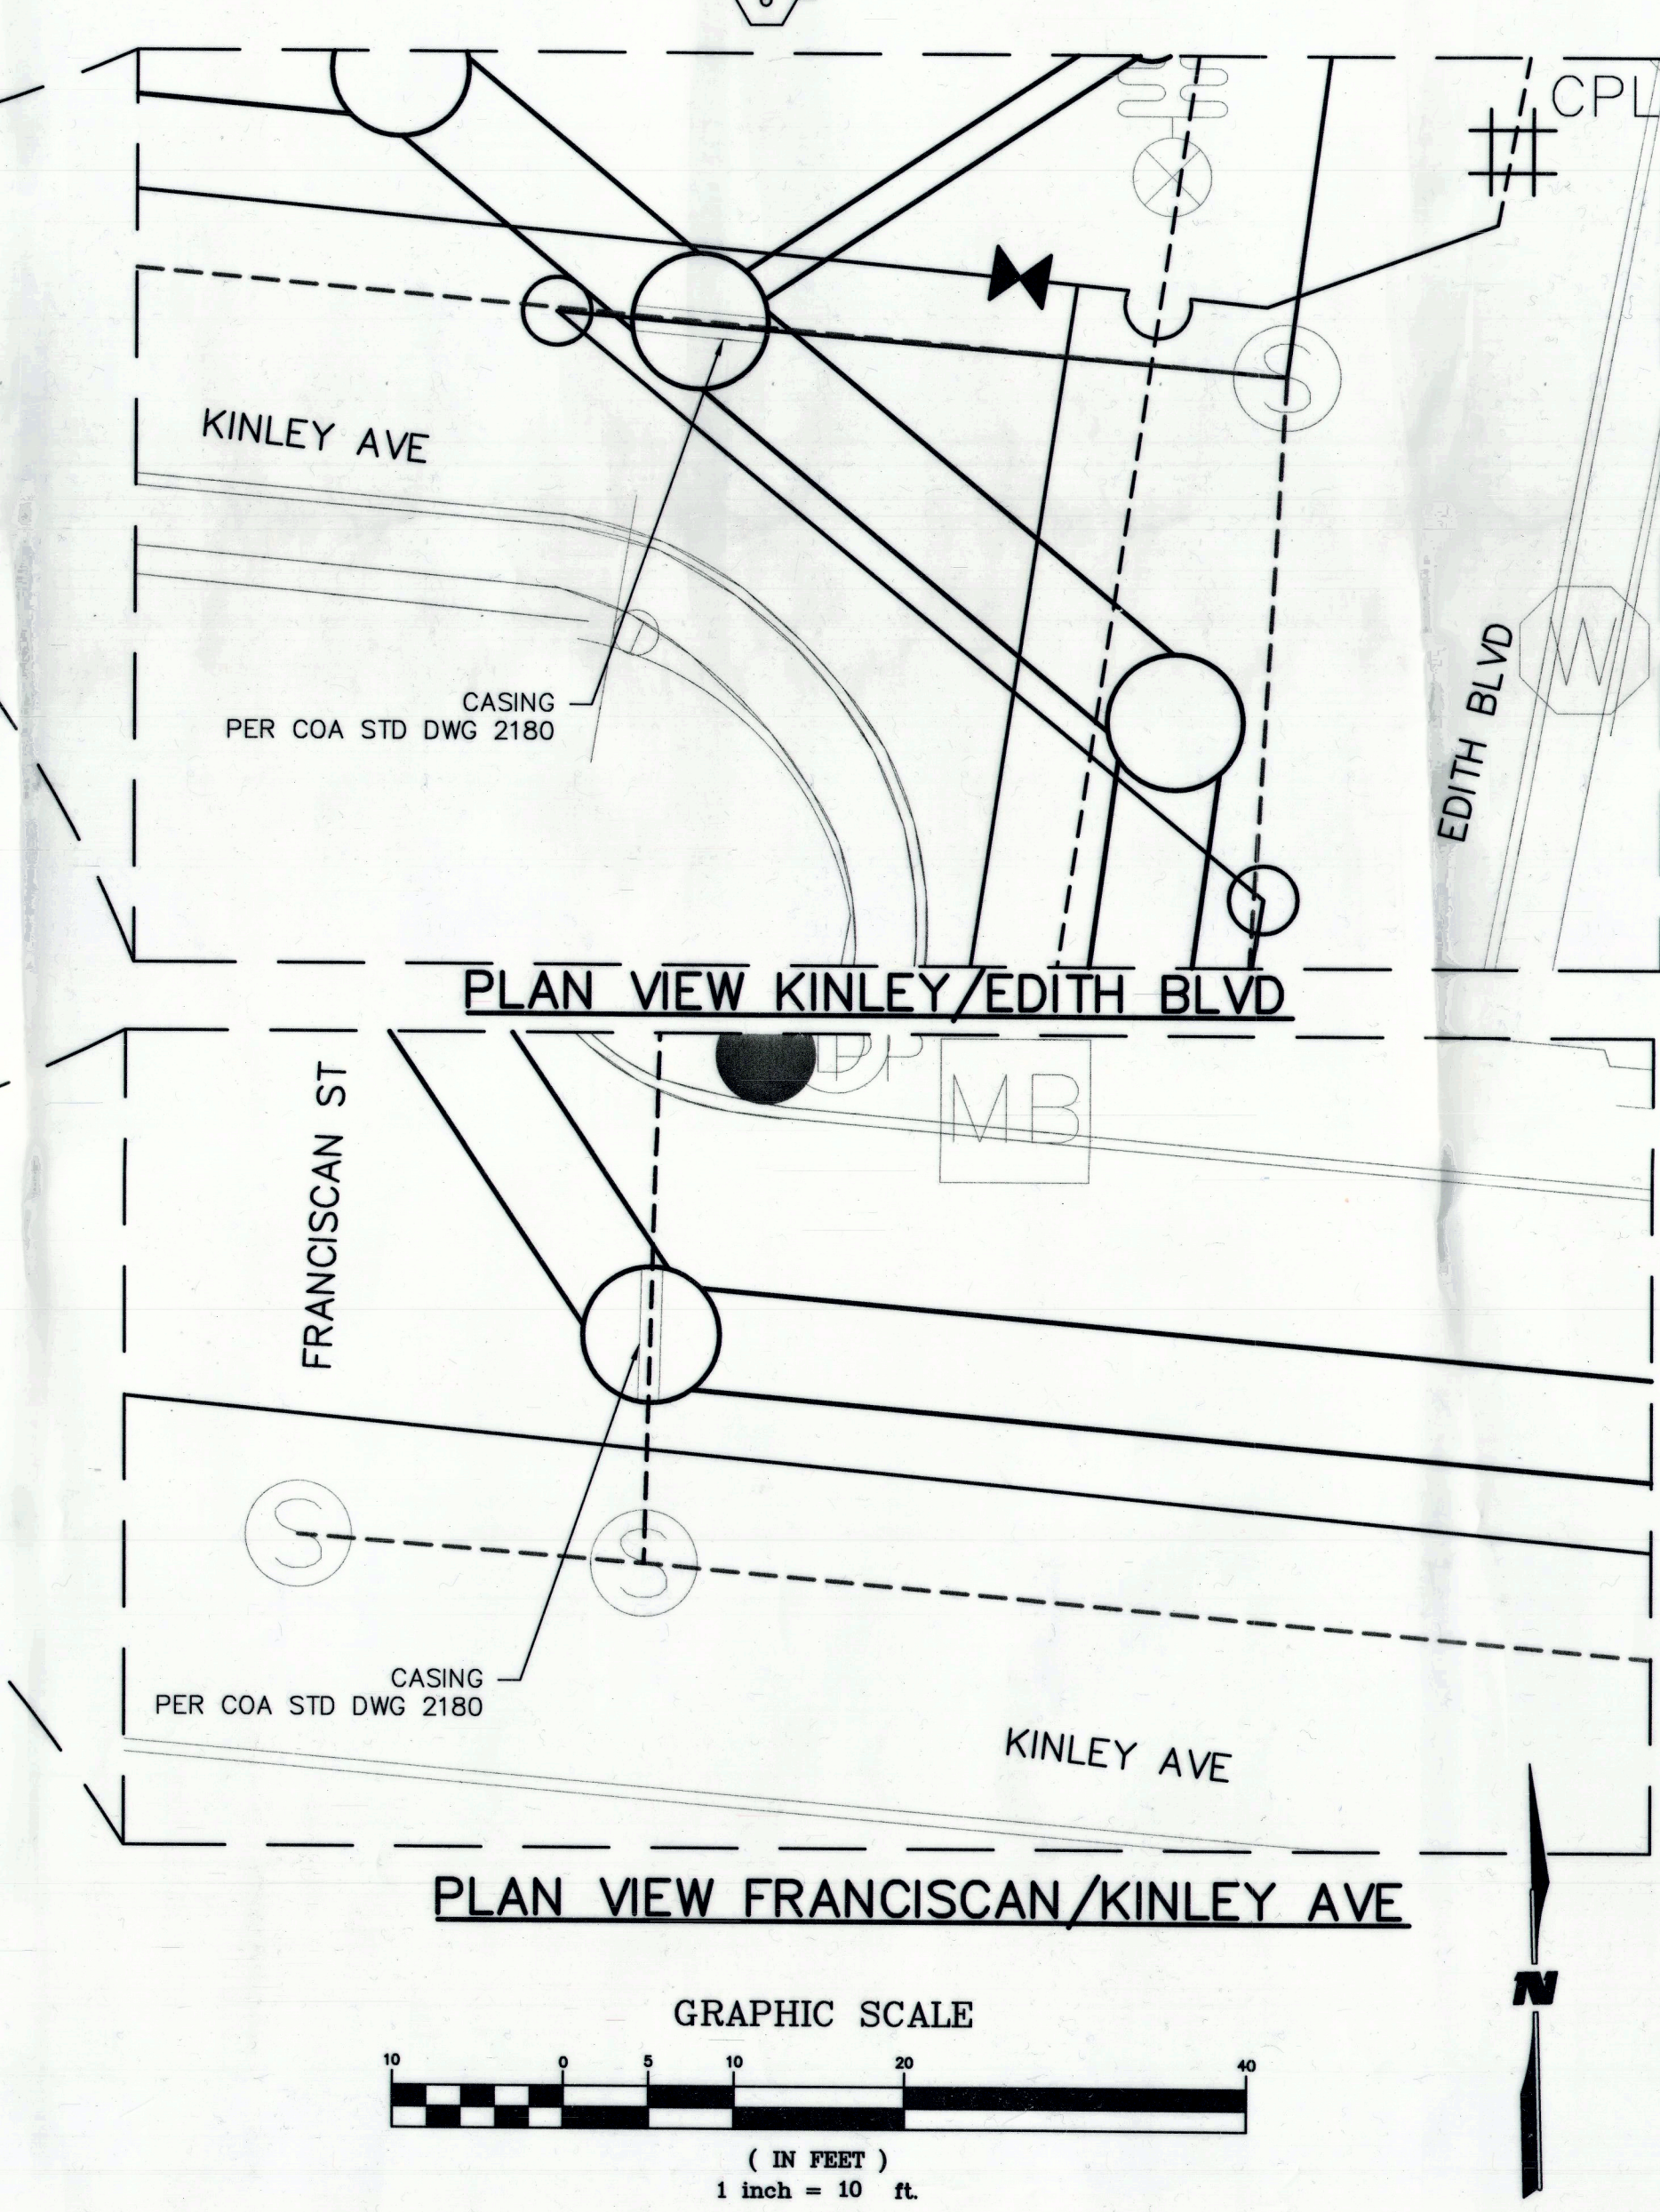

SECTION DETAIL

RECORD DRAWING
DATE: 2/20/07

WILSON & COMPANY
4900 LANG AVENUE NE
ALBUQUERQUE, NEW MEXICO 87109
(505) 348-4000
FAX (505) 348-4072

CITY OF ALBUQUERQUE
DEPARTMENT OF MUNICIPAL DEVELOPMENT
STORM DRAIN DIVISION

TITLE: FLOOD CONTROL ON-CALL CONTRACT
AS-BUILT UTILITY PLAN

Design Review Committee City Engineer Approval

City Project No. 7963.05 Zone Map No. J-14-Z Sheet 1 Of 1

DESIGNED BY: TJA DATE: JUN 2007
DRAWN BY: JLL DATE: JUN 2007
CHECKED BY: MJ DATE: JUN 2007

BERKELEY DEVELOPMENT DIVISION CONTRACT PLAN										ENGINEER'S SEAL		SURVEY INFORMATION		BENCH MARKS		AS BUILT INFORMATION			
												FIELD NOTES		APPROX. 225' WEST OF STOVER AVE. OF THE SOUTH CURB ON EIGHTH STREET, AND IS BELOW TURF. THE STATION IS THEN 0.7 FT FIELD EASEMENT BY WEST SET IN TOP OF A CONCRETE POST. APPROX. 0.2 FT STD. ACS BRASS TABLET STAMPED "1-K13" ELEVATION = 4944.03 FT. DATUM= 1929 NGVD		CONTRACTOR DATE 04/08/20		INSPECTOR'S DATE 07/08/20	
												NO.	BY						