
 
 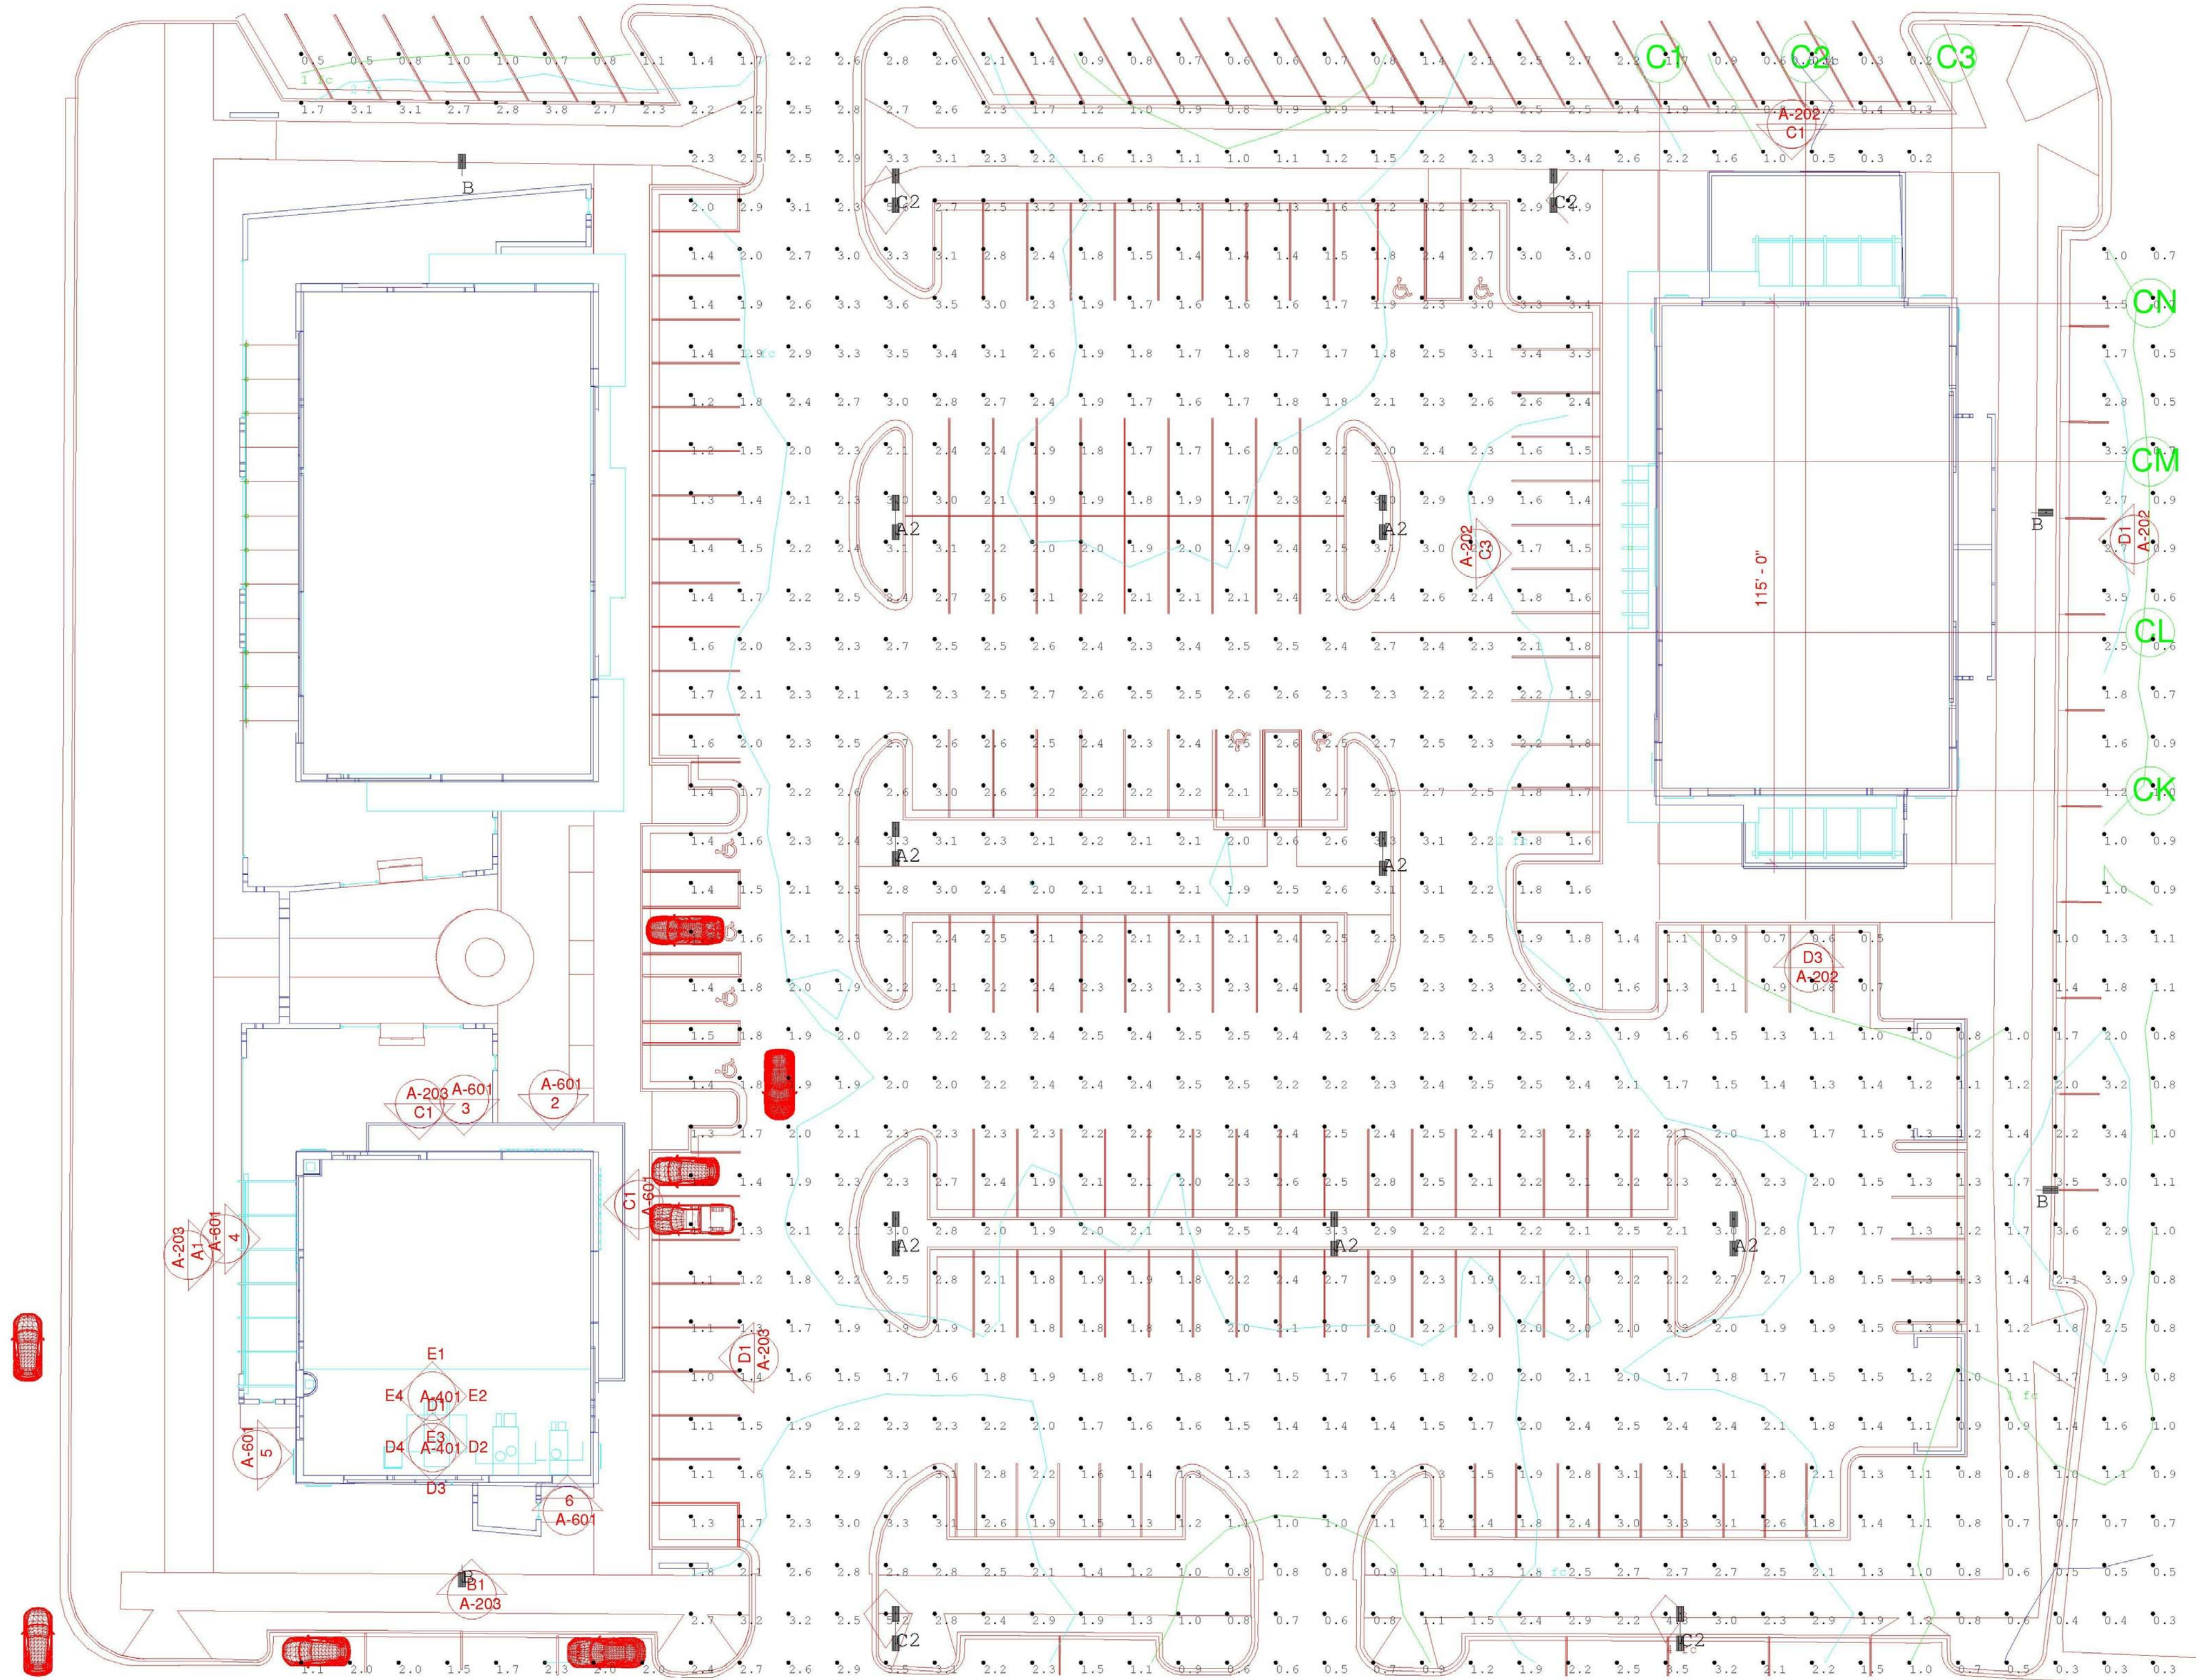




Luminaire Schedule						
Symbol	Qty	Label	Arrangement	Total Lamp Lumens	LLF	Description
	7	A2	BACK-BACK	N.A.	0.900	SPLD # (2)CL1S-48L-5K-5W - 22' FIXT HEIGHT
	4	B	SINGLE	N.A.	0.900	SPLD # CL1S-48LU-5K-2-XX -- 22' FIXT HEIGHT
	4	C2	BACK-BACK	N.A.	0.900	SPLD # (2)CL1S-A-48LU-5K-3 - 22' FIXT HEIGHT

Calculation Summary							
Label	CalcType	Units	Avg	Max	Min	Avg/Min	Max/Min
PARKRING LOT	Illuminance	Fc	1.96	5.6	0.2	9.80	28.00



STUDIO SOUTHWEST ARCHITECTS, INC.
2101 Mountain Rd. NW, Albuquerque, NM 87104
505.843.9639 Fax 505.843.9683
Web Site: www.studioswarch.com
Email: mail@studioswarch.com

© 2013, Studio Southwest Architects, Inc.
Duplication or reproduction by any means without the express written consent of Studio Southwest Architects, Inc. is a violation of federal and international law. The information contained in this document is the intellectual property of Studio Southwest, Inc. and all rights thereto are Reserved. For exceptions refer to the Owner-Architect Agreement.

CONSULTANTS

Architect Engineer

DRB
SUBMITTAL

AIS MASTER PLAN PHASE
1

2400 12TH STREET
ALBUQUERQUE NM 87104

No	Date	Description
Revision Schedule		
ISSUE:	DES DEV	
PROJECT NUMBER:	1513	
FILE:	0000E-101.RVT	
DRAWN BY:	DSJ	
CHECKED BY:	RH	
DATE:	03/30/15	

SHEET TITLE
PHOTOMETRIC SITE
PLAN

E-101