





FIRE ONE PLAN NOTES:

- TYPE RPBA BACKFLOW PREVENTERS FOR THE DOMESTIC WATER AND FIRE LINES SHALL BE PROVIDED INTERNAL TO THE PROPOSED BUILDING PER COA STANDARD DWG 2358. THE BACKFLOW PREVENTERS SHALL BE THE SAME SIZE AS THE TAP/CONNECTION AT THE MAIN LINE.

RESPEC
WATER & NATURAL RESOURCES

9971 JEFFERSON ST NE
ALBUQUERQUE, NM 87109
PHONE: 505.366.4187

DESIGNED	DRAWN	CHECKED	DATE
RUB	JS	HWF	4-13-17

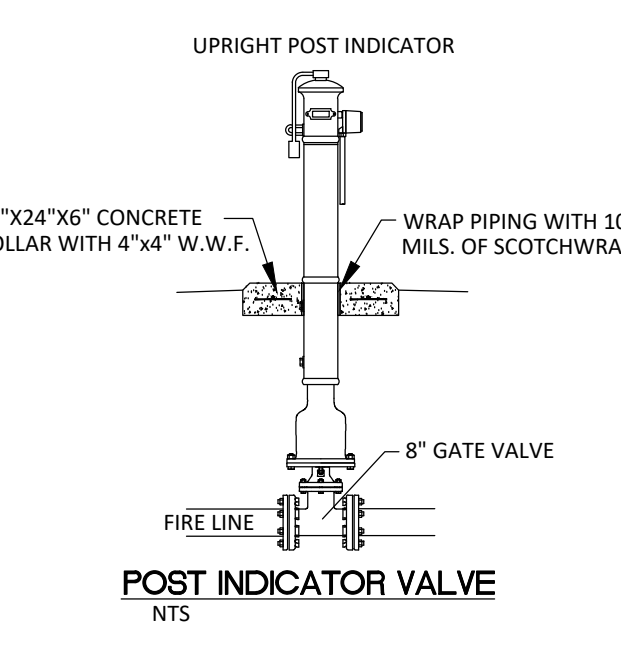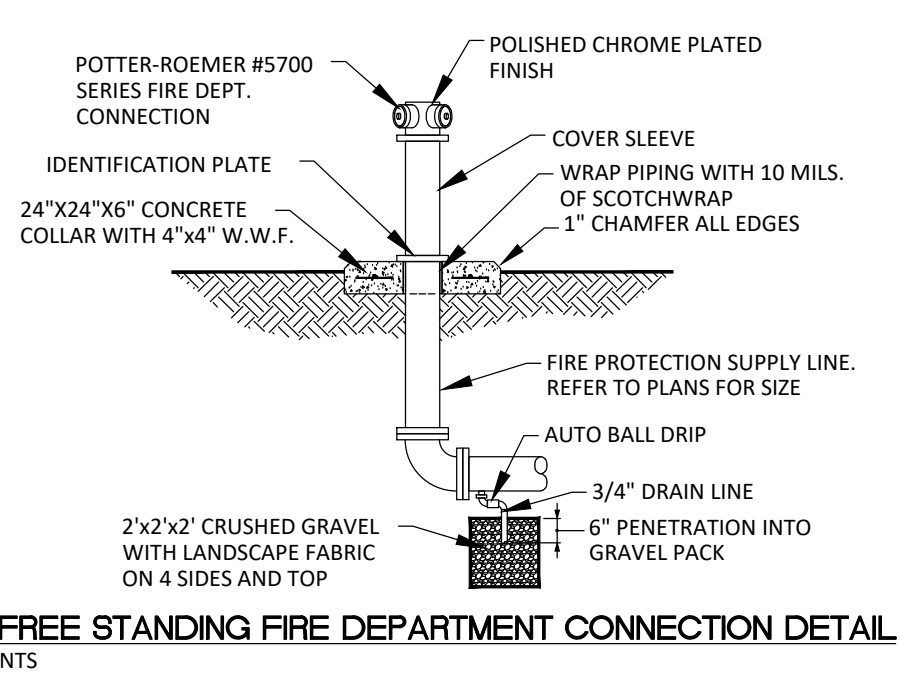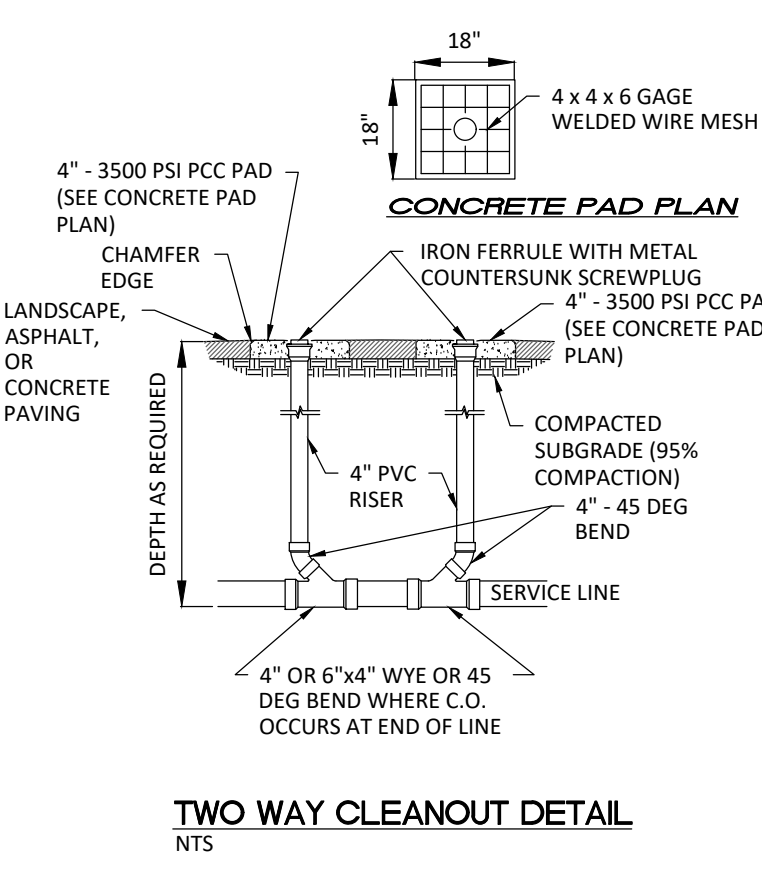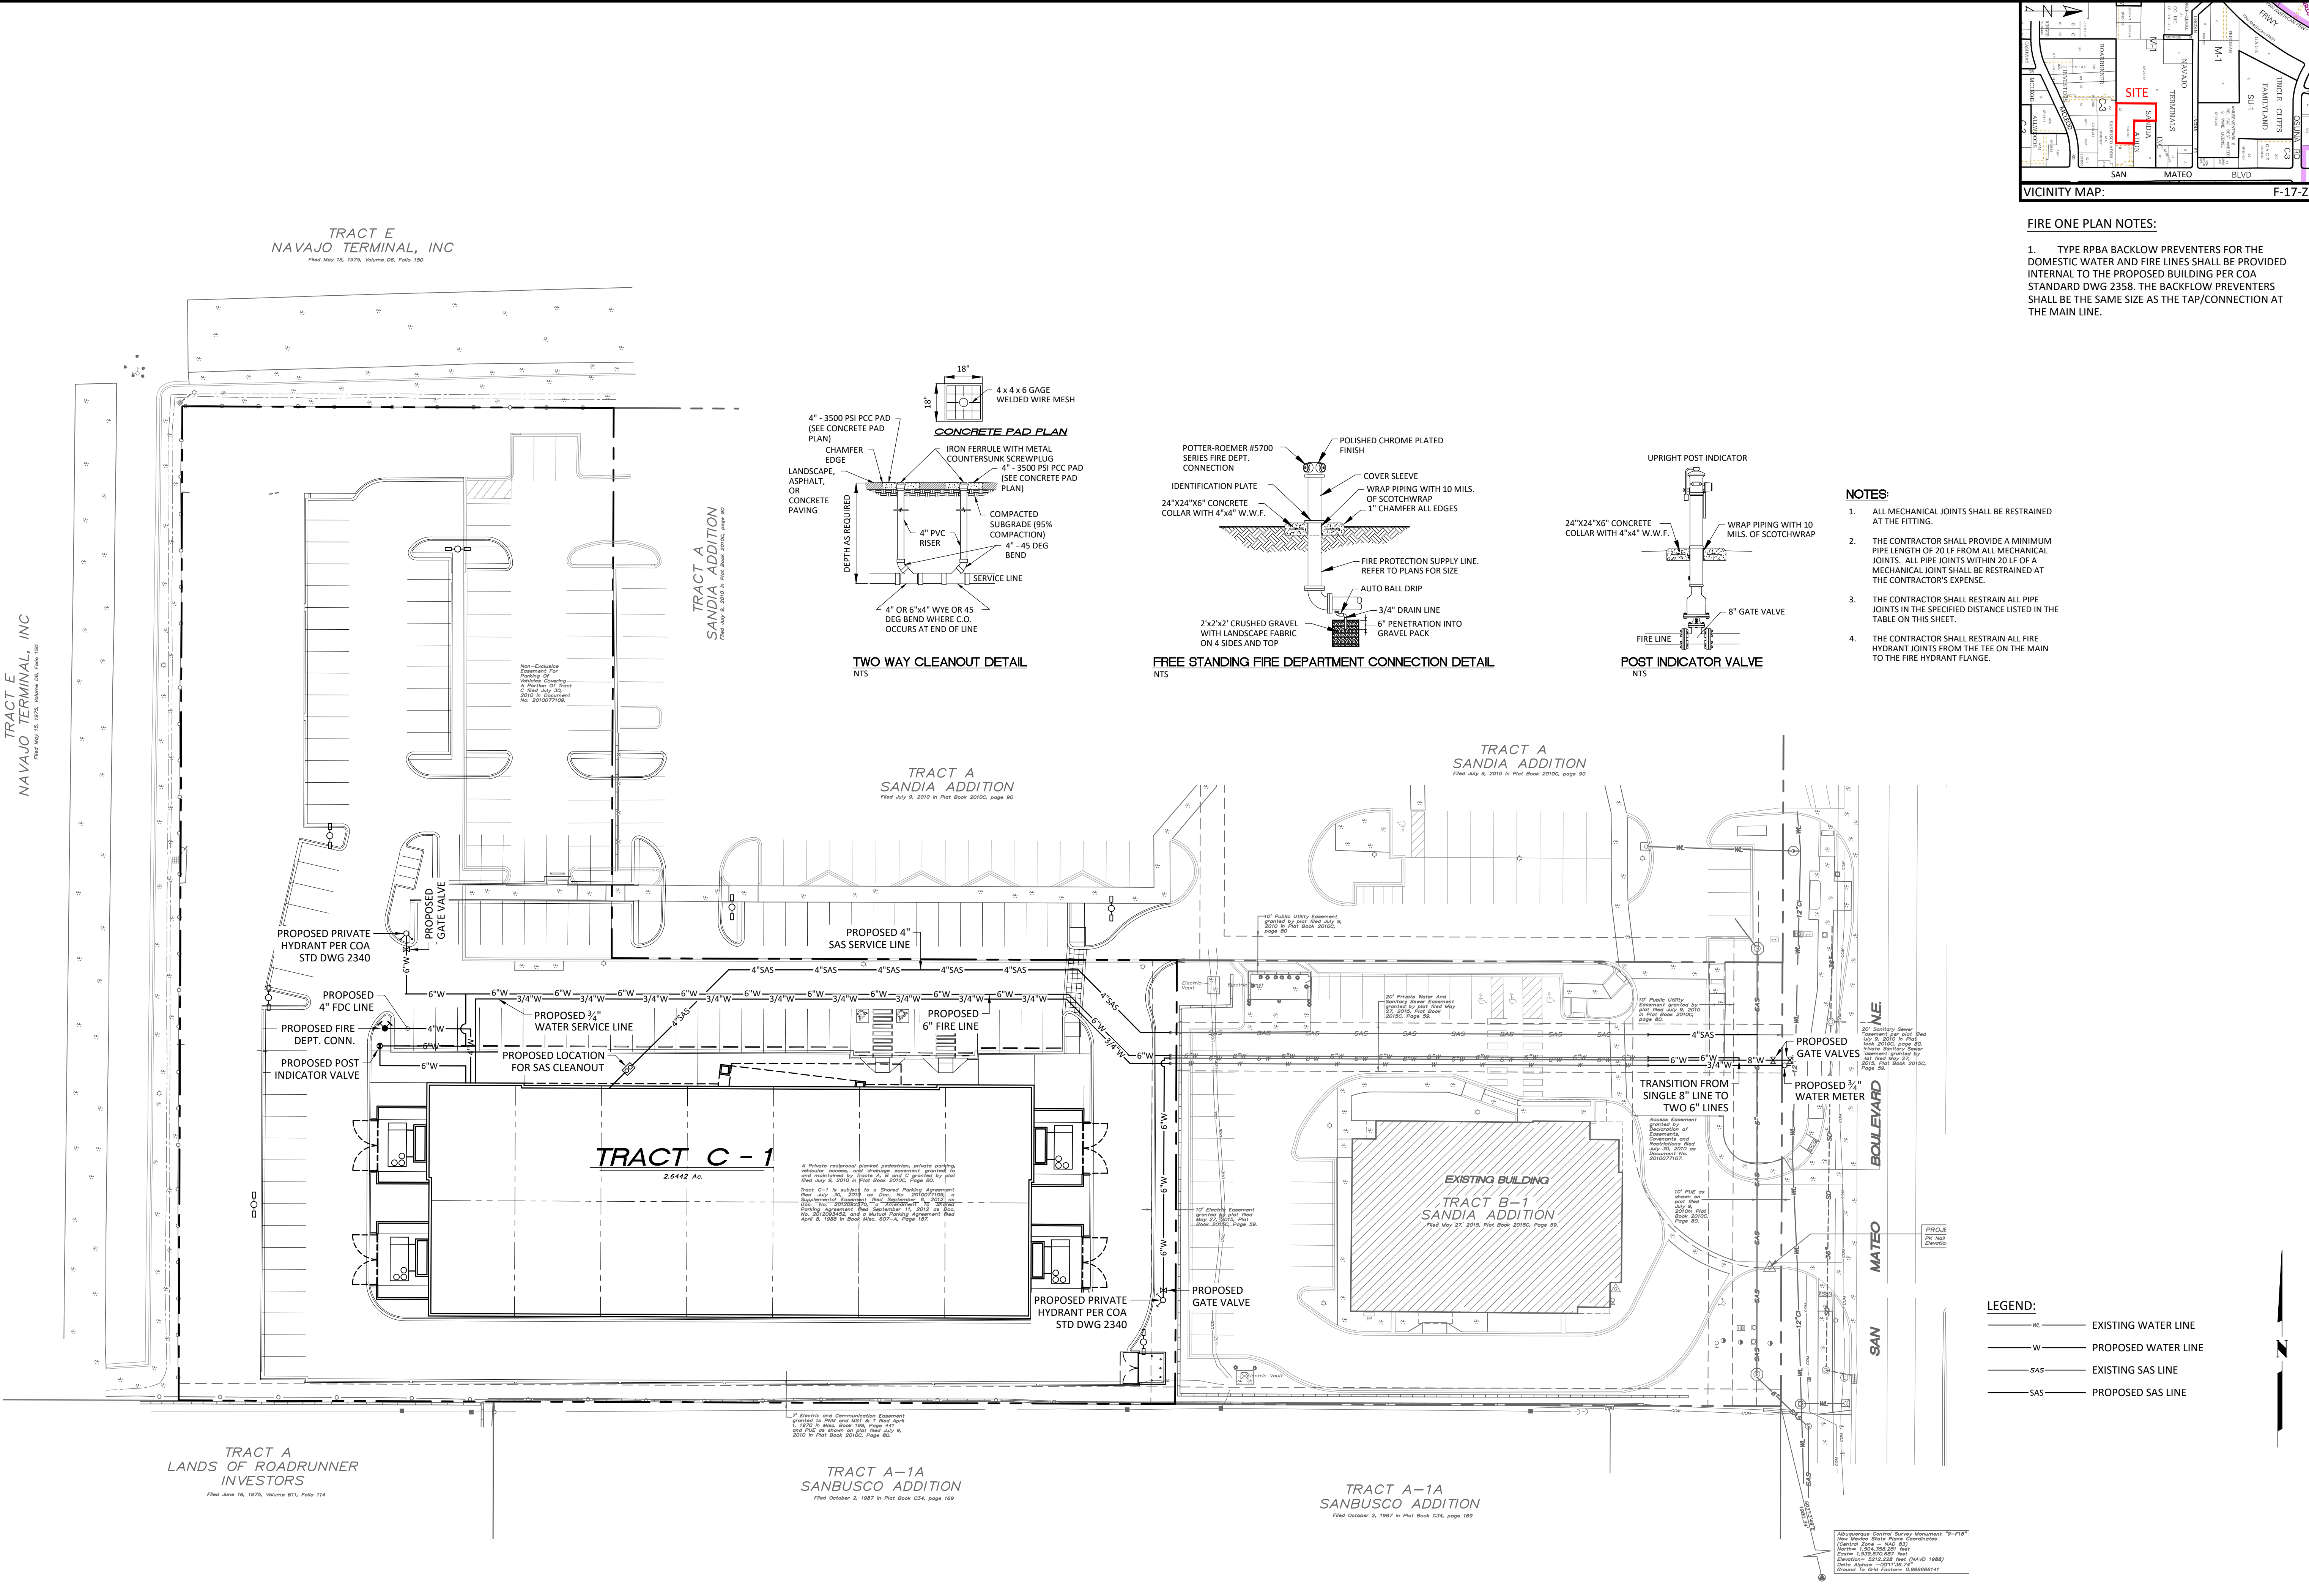

- NOTES:**
- ALL MECHANICAL JOINTS SHALL BE RESTRAINED AT THE FITTING.
 - THE CONTRACTOR SHALL PROVIDE A MINIMUM PIPE LENGTH OF 20 LF FROM ALL MECHANICAL JOINTS. ALL PIPE JOINTS WITHIN 20 LF OF A MECHANICAL JOINT SHALL BE RESTRAINED AT THE CONTRACTOR'S EXPENSE.
 - THE CONTRACTOR SHALL RESTRAIN ALL PIPE JOINTS IN THE SPECIFIED DISTANCE LISTED IN THE TABLE ON THIS SHEET.
 - THE CONTRACTOR SHALL RESTRAIN ALL FIRE HYDRANT JOINTS FROM THE TEE ON THE MAIN TO THE FIRE HYDRANT FLANGE.

**PRELIMINARY
NOT FOR
CONSTRUCTION**

LEGAL DESCRIPTION:
TRACT C-1
SANDIA ADDITION
ALBUQUERQUE, BERNALILLO
COUNTY, NEW MEXICO

**COOL SPRINGZ
TRAMPOLINE PARK**

UTILITY PLAN



SHEET NUMBER:
C-2