

MARK	PRODUCT	DESCRIPTION
AC14	ACRYL PANEL	ACRYL, TRANSPARENT ALUMINUM METALIC
AC15	ACRYL BAND	ACRYL, OPA BLUE TO MATCH ORANGEWATER BLUE
AC16	ACRYL BAND	ACRYL, OPA BLUE TO MATCH ORANGEWATER BLUE
DR11	SECTIONAL DOOR	OVERHEAD DOOR, ALUMINUM GLASS
DR12	SECTIONAL DOOR	OVERHEAD DOOR, SECTIONAL STEEL MODEL NO. 418
GL1	GLASS	CLAY GLASS WITH ANODIZED ALUMINUM FRAME
GL2	GLASS	CLAY GLASS WITH ANODIZED ALUMINUM FRAME
ST1	STUCCO	STUCCO, WHITE DAMASCUS FINISH
ST2	STUCCO	STUCCO, WHITE DAMASCUS FINISH

COLOR SCHEDULE

ELEVATIONS


DRB
APPROVAL
SUBMITTAL

GALLES CHEVROLET
ALBUQUERQUE, NEW MEXICO
JAYNES CORPORATION


Project no. 16-013

ELEV_002


DATE: 10/01/2016
BY: JAYNES
CHECKED: JAYNES
DATE: 10/01/2016
BY: JAYNES
DATE: 10/01/2016
BY: JAYNES

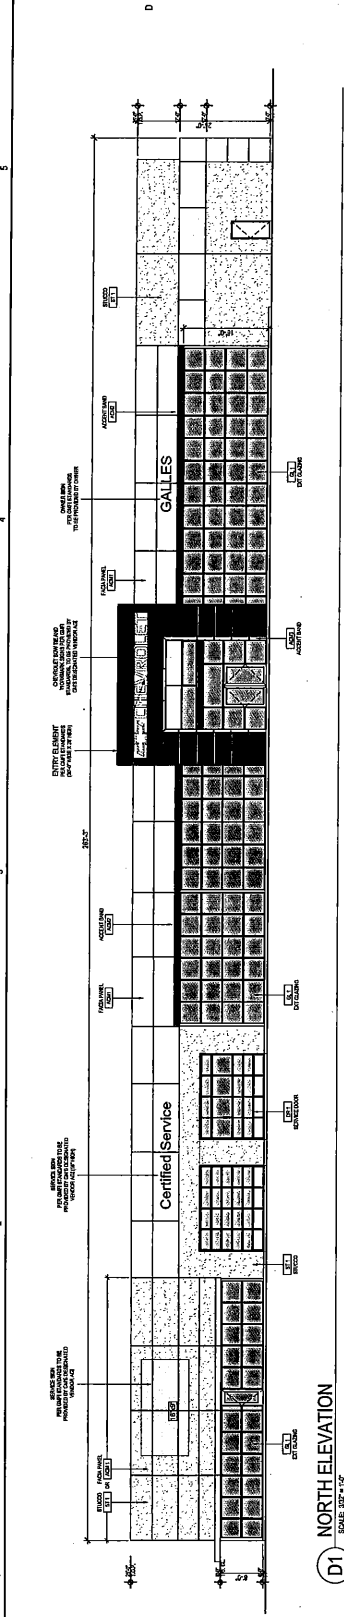


D1 NORTH ELEVATION
SCALE: 1/8" = 1'-0"

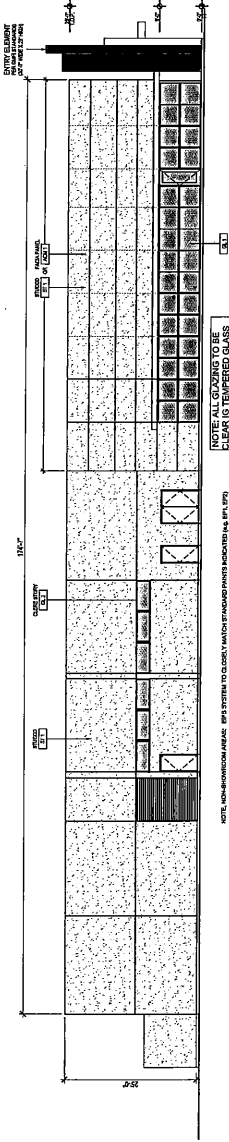


C1 EAST ELEVATION
SCALE: 1/8" = 1'-0"

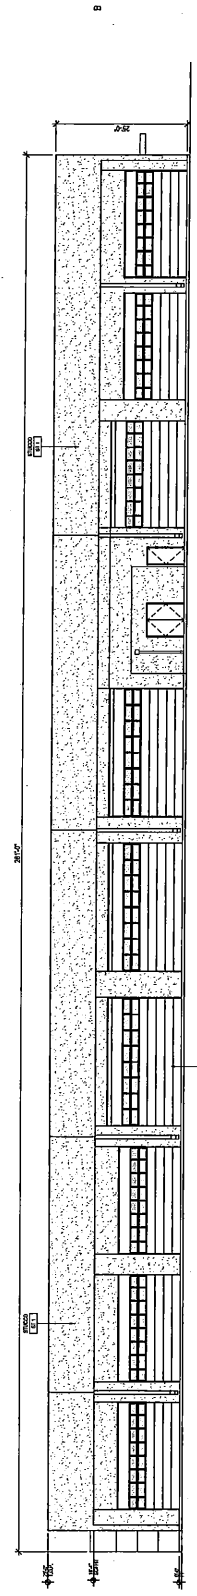


B1 SOUTH ELEVATION
SCALE: 1/8" = 1'-0"

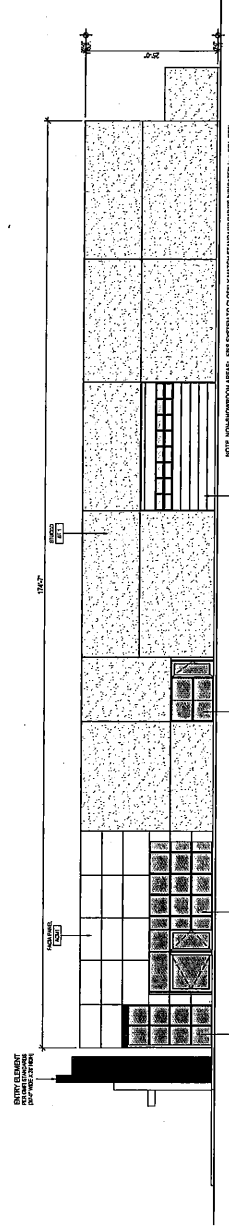

A1 WEST ELEVATION
SCALE: 1/8" = 1'-0"

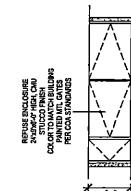

A5 REFUSE ENCLOSURE
SCALE: 1/8" = 1'-0"

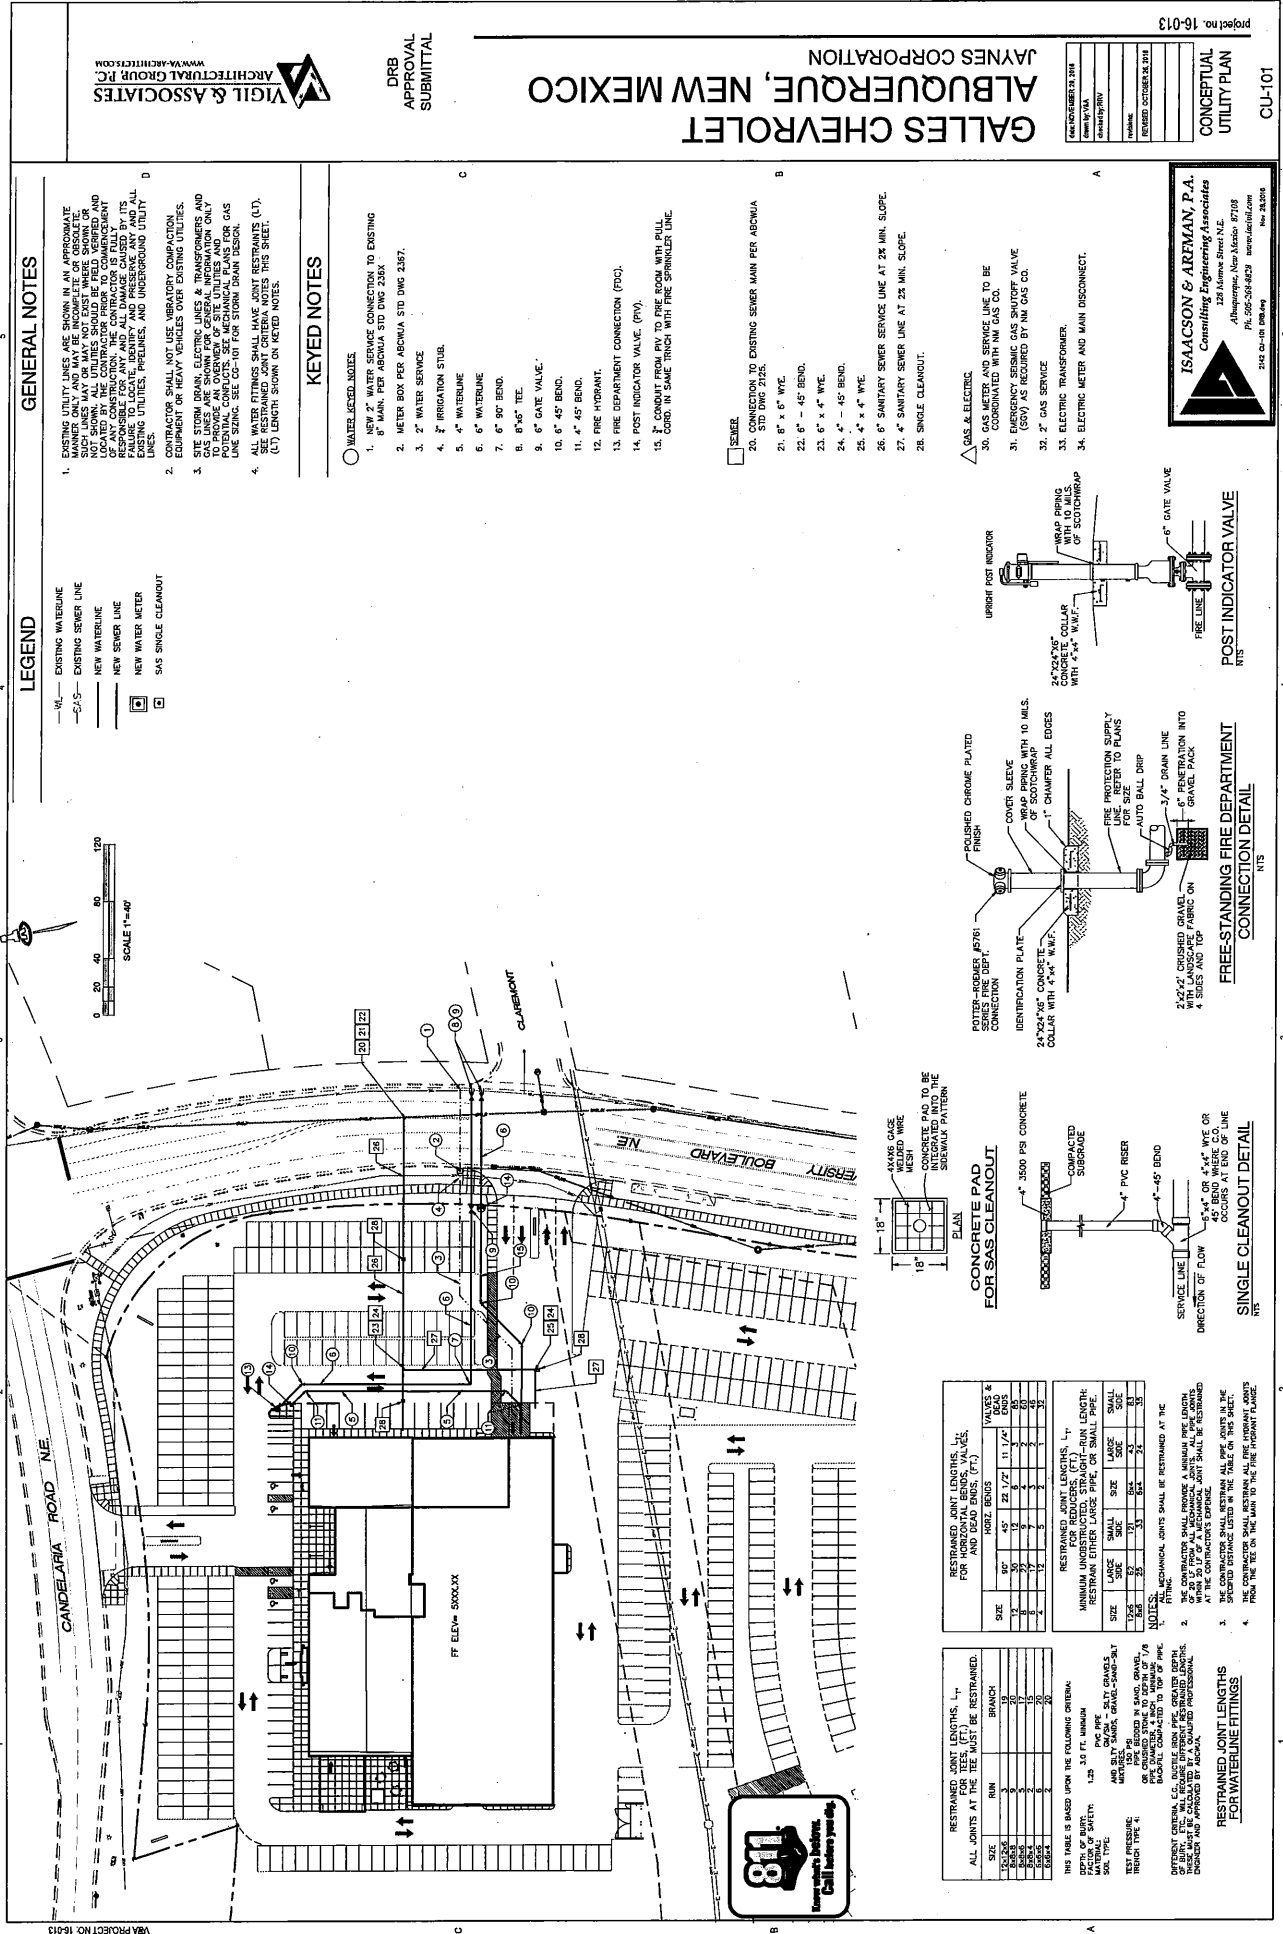

- LEGEND**
- VL— EXISTING WATERLINE
 - 2.5— EXISTING SEWER LINE
 - NEW WATERLINE
 - NEW SEWER LINE
 - NEW WATER METER
 - SAS SINGLE CLEANOUT




GENERAL NOTES

- EXISTING UTILITY LINES ARE SHOWN IN AN APPROXIMATE MANNER ONLY AND MAY BE SHOWN IN AN APPROXIMATE LOCATION. THE CONTRACTOR SHALL BE RESPONSIBLE FOR LOCATING AND VERIFYING THE LOCATION OF ALL EXISTING UTILITIES PRIOR TO CONSTRUCTION. THE CONTRACTOR SHALL BE RESPONSIBLE FOR ANY AND ALL DAMAGE CAUSED BY ITS FAILURE TO LOCATE, IDENTIFY AND PRESERVE ANY AND ALL EXISTING UTILITIES, PRELINES, AND UNDERGROUND UTILITY LINES.
- CONTRACTOR SHALL NOT USE VIBRATORY COMPACTION EQUIPMENT OR HEAVY VEHICLES OVER EXISTING UTILITIES AND EQUIPMENT.
- SITE STORM DRAIN, ELECTRIC LINES & TRANSFORMERS AND GAS LINES SHALL BE SHOWN IN THE EXISTING CONDITIONS ONLY TO PROVIDE AN OVERVIEW OF SITE UTILITIES AND TO INDICATE THE LOCATION OF EXISTING UTILITIES. THE CONTRACTOR SHALL BE RESPONSIBLE FOR VERIFYING THE LOCATION OF ALL EXISTING UTILITIES PRIOR TO CONSTRUCTION.
- ALL WATER FITTINGS SHALL HAVE JOINT RESTRAINTS (JR). SEE RESTRAINED JOINT CRITERIA NOTES THIS SHEET. (JR) LENGTH SHOWN ON KEYED NOTES.

- KEYED NOTES**
- WATER-KEYED NOTES
- NEW 2" WATER SERVICE CONNECTION TO EXISTING 6" MAIN, PER ADEQUA STD DMC 2387.
 - METER BOX PER ADEQUA STD DMC 2387.
 - 2" WATER SERVICE
 - 2" IRRIGATION STUB
 - 4" WATERLINE
 - 6" WATERLINE
 - 6" 90° BEND
 - 8" 45° TEE
 - 6" GATE VALVE
 - 6" 45° BEND
 - 4" 45° BEND
 - FIRE HYDRANT
 - FIRE DEPARTMENT CONNECTION (FDC)
 - POST INDICATOR VALVE (PIV)
 - 2" 90° BEND FROM PIV TO FIRE ROOM WITH PULL COUPLER IN SAME DIRECTION WITH FIRE SPRINKLER LINE

- SEWER
- 2" 90° BEND TO EXISTING SEWER MAIN PER ADEQUA STD DMC 2120
 - 8" x 8" WYE
 - 6" - 45° BEND
 - 6" x 4" WYE
 - 4" - 45° BEND
 - 4" x 4" WYE
 - 6" SANITARY SEWER SERVICE LINE AT 2% MIN. SLOPE
 - 4" SANITARY SEWER SERVICE LINE AT 2% MIN. SLOPE
 - SINGLE CLEANOUT

- △ GAS & ELECTRIC
- GAS METER AND SERVICE LINE TO BE COORDINATED WITH NM GAS CO.
 - EMERGENCY SEISMIC GAS SHUTOFF VALVE (SGSV) AS REQUIRED BY NM GAS CO.
 - 2" GAS SERVICE
 - ELECTRIC TRANSFORMER
 - ELECTRIC METER AND MAIN DISCONNECT

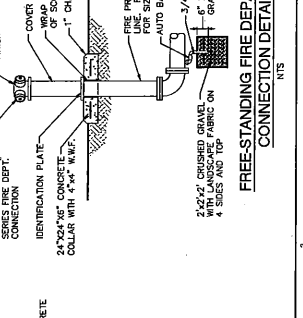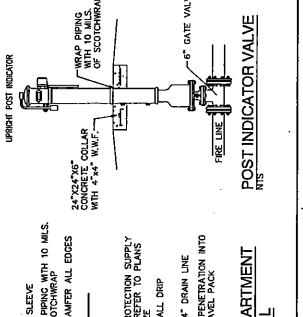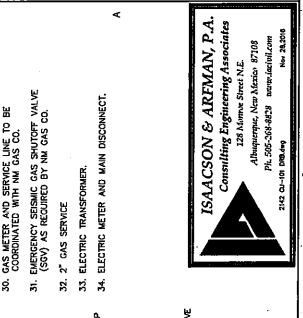

RESTRAINED JOINT LENGTHS, L_R

FOR HORIZONTAL BENDS, VALVES, AND FITTINGS (F.T.)

SIZE	45°	90°	180°	270°	360°
1/2"	12	12	12	12	12
3/4"	12	12	12	12	12
1"	12	12	12	12	12
1 1/2"	12	12	12	12	12
2"	12	12	12	12	12
3"	12	12	12	12	12
4"	12	12	12	12	12
6"	12	12	12	12	12
8"	12	12	12	12	12
10"	12	12	12	12	12
12"	12	12	12	12	12

RESTRAINED JOINT LENGTHS, L_R

FOR HORIZONTAL BENDS, VALVES, AND FITTINGS (F.T.)

SIZE	45°	90°	180°	270°	360°
1/2"	12	12	12	12	12
3/4"	12	12	12	12	12
1"	12	12	12	12	12
1 1/2"	12	12	12	12	12
2"	12	12	12	12	12
3"	12	12	12	12	12
4"	12	12	12	12	12
6"	12	12	12	12	12
8"	12	12	12	12	12
10"	12	12	12	12	12
12"	12	12	12	12	12

RESTRAINED JOINT LENGTHS, L_R

FOR HORIZONTAL BENDS, VALVES, AND FITTINGS (F.T.)

SIZE	45°	90°	180°	270°	360°
1/2"	12	12	12	12	12
3/4"	12	12	12	12	12
1"	12	12	12	12	12
1 1/2"	12	12	12	12	12
2"	12	12	12	12	12
3"	12	12	12	12	12
4"	12	12	12	12	12
6"	12	12	12	12	12
8"	12	12	12	12	12
10"	12	12	12	12	12
12"	12	12	12	12	12

