


○ WATER LINE NOTES:

- 1. TIE INTO EXIST. 6" PVC WATERLINE, INSTALL 3/4" WATER SERVICE PER COA STD. DWG 2362.
- 2. INSTALL METER BOX AND LID PER COA STD. DWG 2366.
- 3. INSTALL 3/4" WATER METER
- 4. INSTALL 1" PVC WATERLINE.
- 5. INSTALL 3/4" X 1" REDUCER
- 6. EXISTING 6" TEE, WATERLINE STUB W/GATE VALVE
- 7. EXISTING 6" PVC WATERLINE
- 8. EXISTING 6" GATE VALVE
- 9. EXISTING FIRE HYDRANT


□ SEWER LINE NOTES:

- 1. EXISTING 6" PVC SAS SERVICE (30 LF) , INV.=5019.78
- 2. TIE INTO EXISTING SAS SERVICE STUB.
- 3. INSTALL DOUBLE 6" CLEANOUT PER CITY OF ALBUQUERQUE STAN
- 4. CONNECT INTO BUILDING STUB.
- 5. 6" SANITARY SEWER LINE, AT 2% MIN. SLOPE.
- 6. EXISTING SAS MANHOLE, RIM=5027.59, INV. NW=5019.72.
- 7. EXISTING 8" PVC SANITARY SEWER LINE.

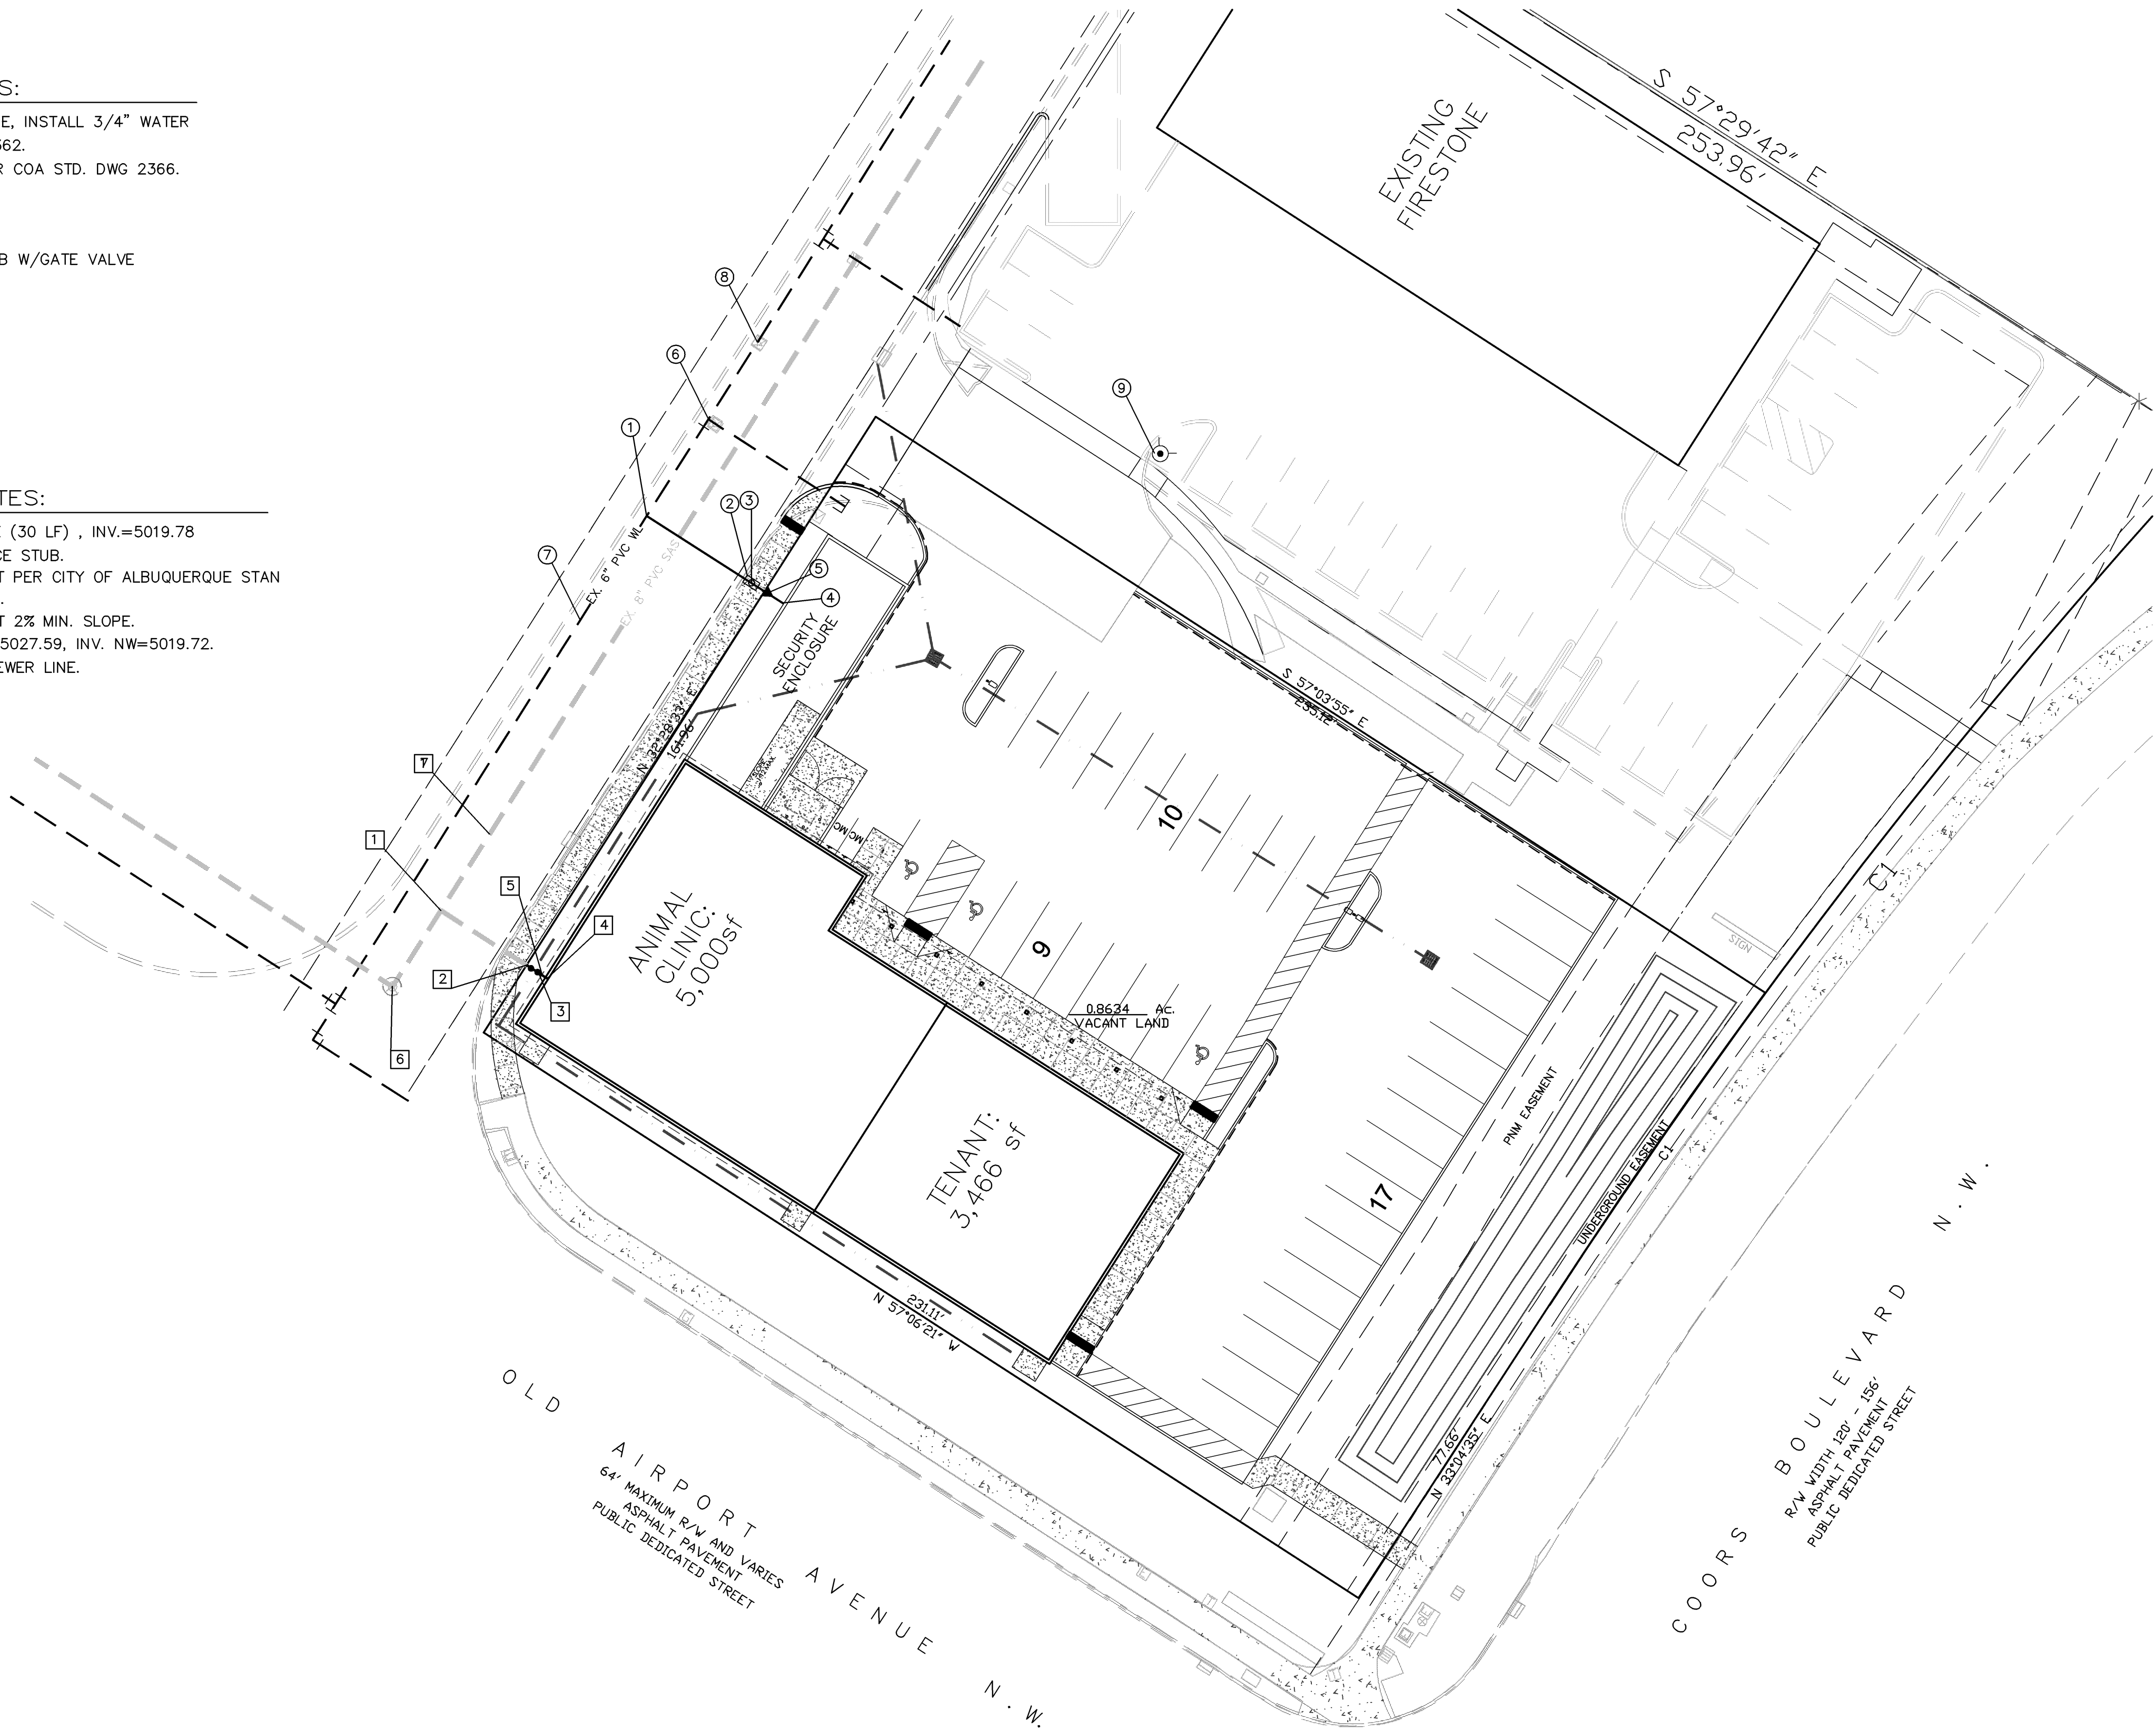


LEGEND

- EXISTING SAS MANHOLE
- EXISTING SD MANHOLE
- EXISTING GATE VALVE
- EX. 10" WL---
- EXISTING WATERLINE
- EXISTING FIRE HYDRANT
- EX. 8" SAS---
- EXISTING SANITARY SEWER LINE
- E ELECTRIC LINE
- 8" SAS NEW SANITARY SEWER LINE
- 6" WL NEW WATERLINE
- DOUBLE CLEANOUT
- NEW WATER SERVICE
- NEW SAS SERVICE
- NEW SAS MANHOLE
- STORM SEWER MANHOLE
- SINGLE SERVICE METER
- DOUBLE SERVICE METER
- NEW GATE VALVE
- NEW FIRE HYDRANT
- TEE
- BEND
- CAP (WL)
- NEW REDUCER
- NEW 4" SINGLE CLEANOUT
- NEW 4" DOUBLE CLEANOUT

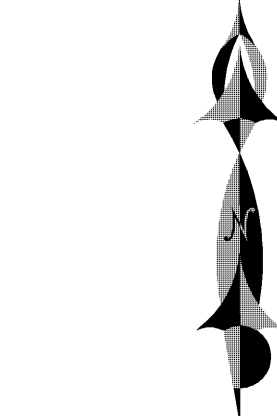

GRAPHIC SCALE

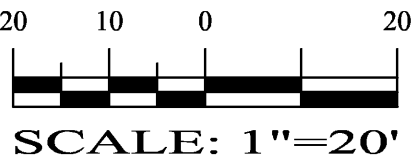

REZA AFAGHPOUR
P.E. #11814

SBS CONSTRUCTION
AND ENGINEERING, LLC

10209 SNOWFLAKE CT., NW
ALBUQUERQUE, NEW MEXICO 87114
(505)899-5570

SOUTHWEST VETERINARY MEDICAL CENTER
LOT 6, LOWES SUBD., ALBUQUERQUE, NEW MEXICO
MASTER UTILITY PLAN

DRAWING:	DRAWN BY:	DATE:	SHEET #
201404-MU.DWG	SH-B	1-24-2014	C102