


- LEGEND**
- ELECTRICAL POWER POLE
 - ELECTRICAL GUY WIRE
 - ELECTRICAL LIGHT POLE
 - ELECTRICAL RISER
 - ELECTRICAL BOX
 - ELECTRICAL TRANSFORMER
 - ELECTRICAL AIR CONDITIONER UNIT
 - UTILITY GAS VALVE
 - UTILITY GAS METER
 - UTILITY GAS VAULT
 - UTILITY WATER VALVE
 - UTILITY SANITARY CLEAN OUT
 - UTILITY SANITARY SEWER MANHOLE
 - UTILITY STORM SEWER MANHOLE
 - UTILITY TELEPHONE PEDESTAL
 - UTILITY FIBER OPTIC PEDESTAL
 - UTILITY UNKNOWN PEDESTAL
 - UTILITY ANTENNA TOWER
 - UTILITY FIRE HYDRANT
 - FF(5048.53) SITE FINISH FLOOR ELEVATION
 - SITE BOLLARD
 - SITE SIGN
 - SITE GATE
 - SITE PICNIC TABLE
 - SITE ROOF DRAIN
 - SITE DECIDUOUS TREE
 - SITE CONTROL POINT
 - SITE PARKING BUMPER
 - SITE PARKING STRIP
 - SITE CHAINLINK FENCE
 - SITE BARB WIRE FENCE
 - SITE CMP


- LEGEND**
- SITE PICTURE LOCATION WINUMBER
 - SITE BOLLARD
 - SITE SINGLE-POST SIGN
 - SITE DOUBLE-POST SIGN
 - SITE PARKING BUMPER
 - SITE GATE
 - ELECTRICAL POWER POLE
 - ELECTRICAL GUY WIRE
 - ELECTRICAL PULL BOX
 - UTILITY TELEPHONE PEDESTAL
 - UTILITY TELEPHONE PULL BOX
 - UTILITY WATER FAUCET
 - UTILITY FIRE HYDRANT
 - UTILITY WATER VALVE
 - HVAC EQUIPMENT AC EQUIPMENT
 - UTILITY GAS METER
 - UTILITY CLEAN OUT
 - SITE PROPANE TANK

- LINE STYLES**
- SITE CHAIN LINK FENCE
 - SITE BLOCK WALL
 - UTILITY UNDERGROUND TELEPHONE LINE
 - UTILITY WATER LINE
 - UTILITY TELEPHONE LINE
 - UTILITY GAS LINE
 - UTILITY SANITARY SEWER LINE
 - ELECTRICAL OVERHEAD ELECTRIC LINE
 - ELECTRICAL UNDERGROUND ELECTRIC LINE

- LEGEND:**
- ELECTRICAL OVERHEAD LINE
 - ELECTRICAL UNDERGROUND LINE
 - UTILITY GAS LINE
 - UTILITY WATER LINE
 - UTILITY SANITARY SEWER LINE
 - UTILITY STORM SEWER LINE
 - UTILITY FIBER OPTIC LINE
 - UTILITY TELEPHONE LINE

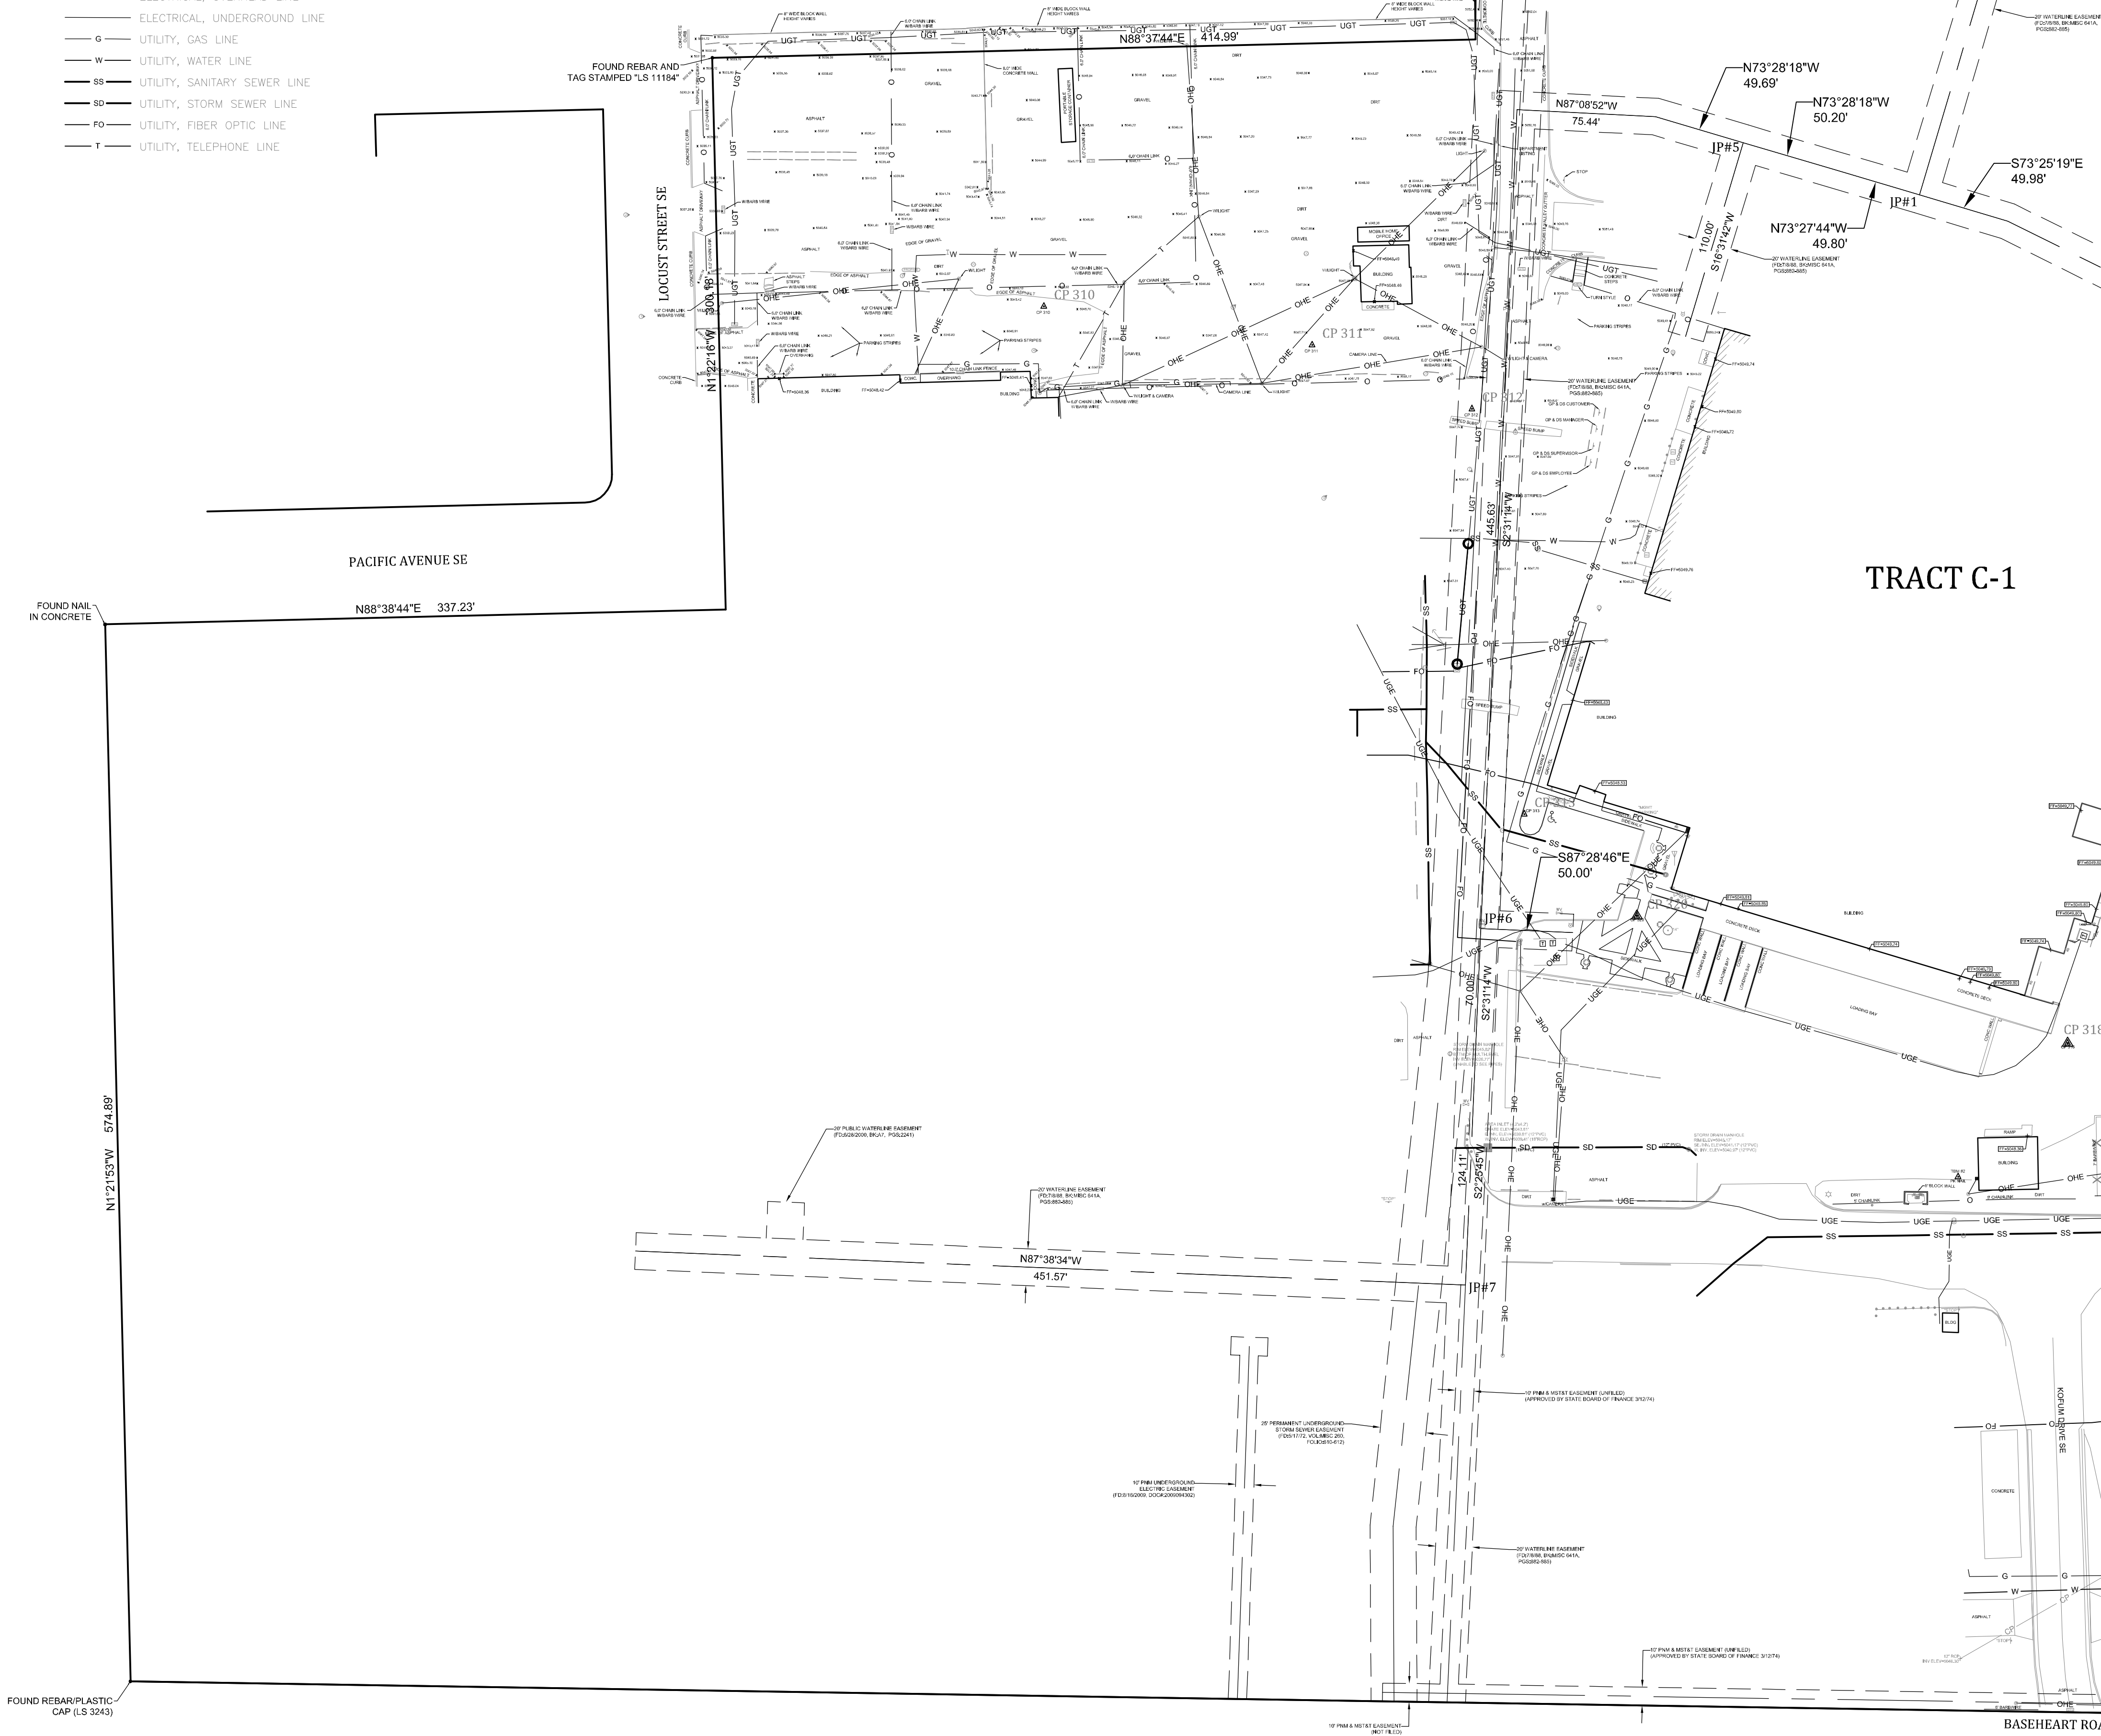

BOUNDARY/TOPO SURVEY
1" = 50'

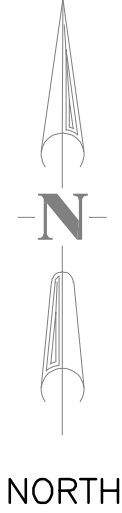

SURVEYOR'S CERTIFICATE:

I HEREBY CERTIFY THAT THIS BOUNDARY/TOPO SURVEY AND THE NOTES SHOWN HEREON WERE PREPARED UNDER MY DIRECTION FROM A SURVEY PERFORMED IN THE FIELD. TO THE BEST OF MY KNOWLEDGE, INFORMATION AND BELIEF THIS PLAT MEETS OR EXCEEDS THE REQUIREMENTS OF THE "MINIMUM STANDARDS FOR THE LAND SURVEYING IN NEW MEXICO". I FURTHER CERTIFY THAT THIS SURVEY IS NOT A LAND DIVISION OR SUBDIVISION AS DEFINED IN THE NEW MEXICO SUBDIVISION ACT AND THAT THIS IS A BOUNDARY SURVEY PLAT OF AN EXISTING TRACT.

BENJAMIN M. ARAGON NMP5 15268 DATE

PROJECT NO: 10-600-084-00			PROJECT NAME			SEAL		CONSULTANTS		WILSON & COMPANY 4900 Long Avenue NE Albuquerque, NM 87109 Phone: (505) 348-4000
DRAWN BY: PAJ			LINCOLN COMPLEX BOUNDARY/TOPO SURVEY							
CHECKED BY: BMA										
SHEET <u>1</u> OF <u>3</u>			ALBUQUERQUE, NEW MEXICO							
MARK	DATE	DESCRIPTION								