

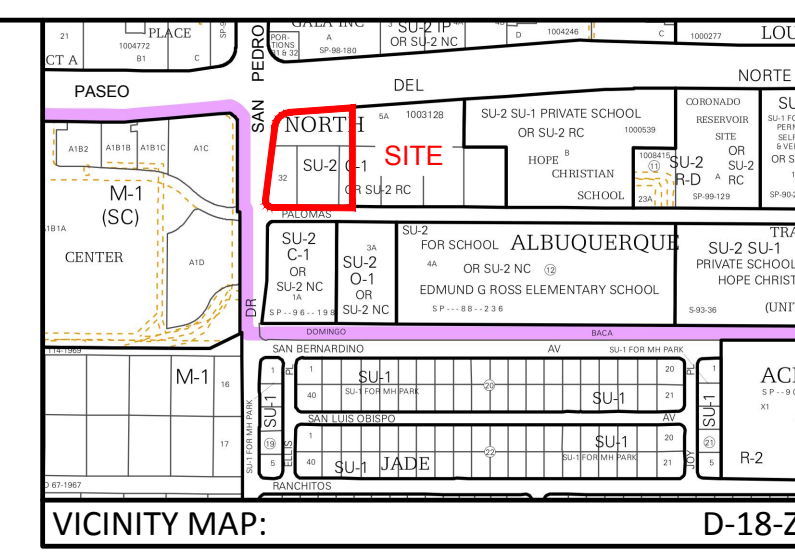
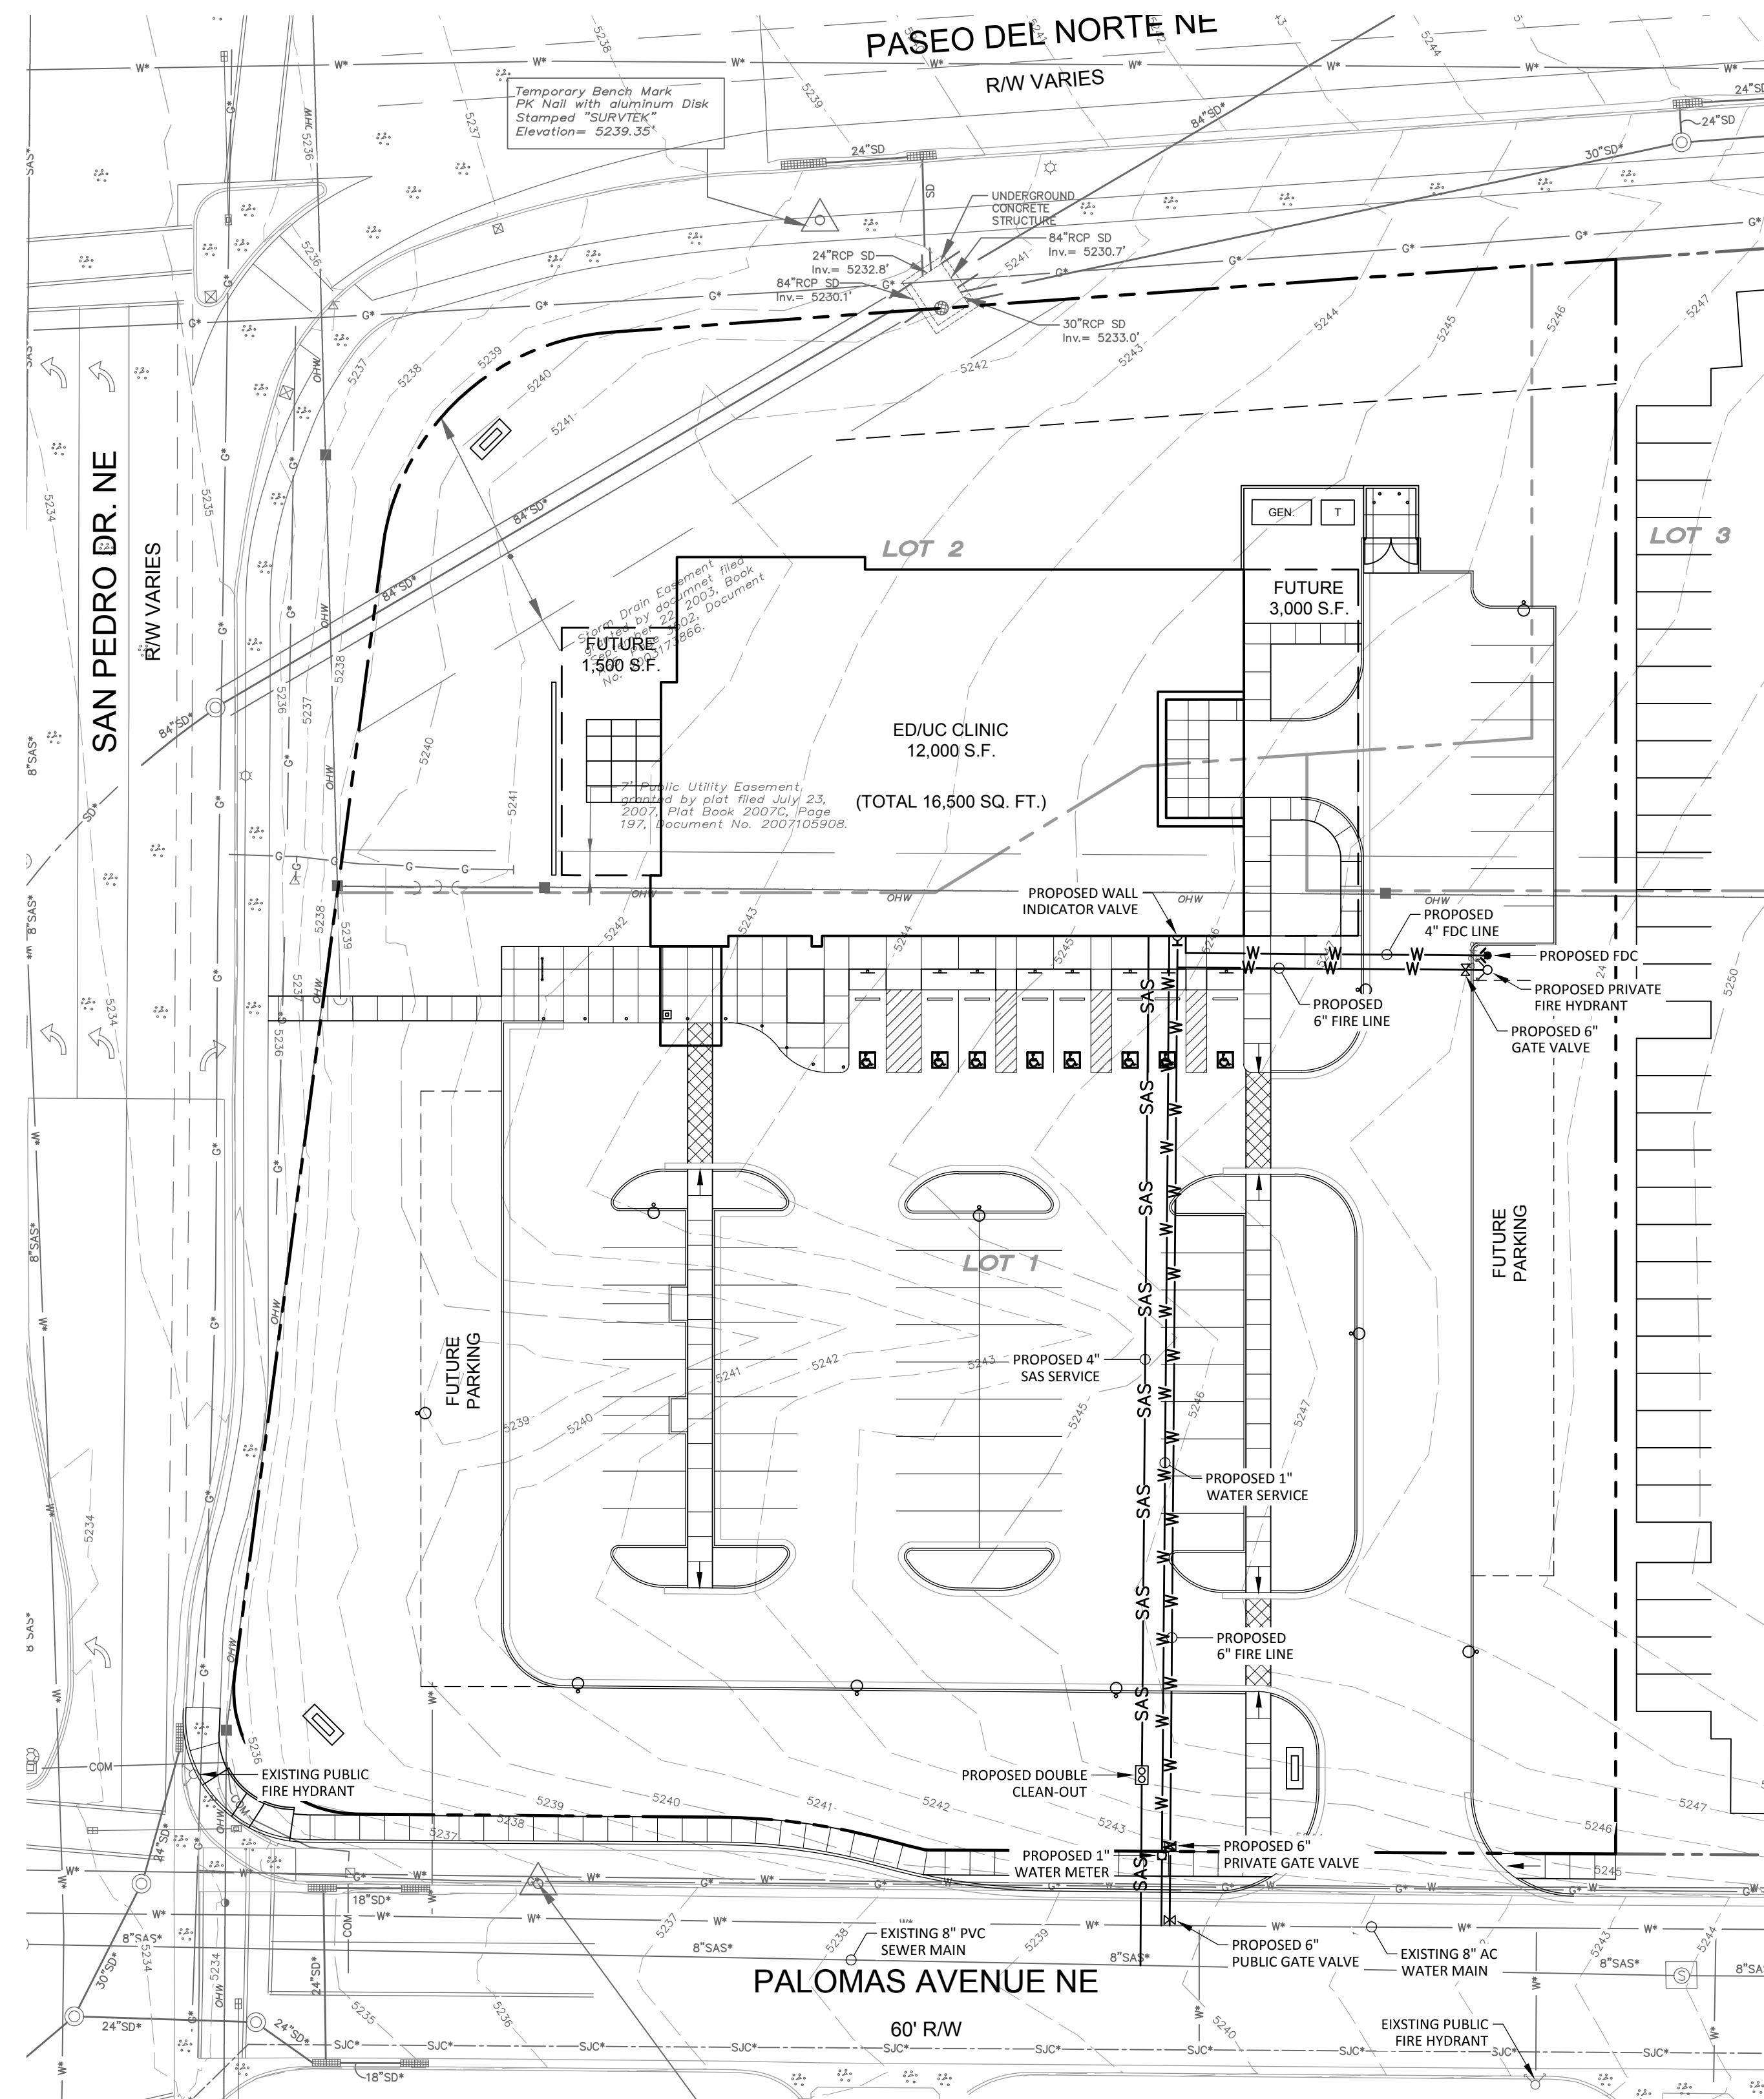


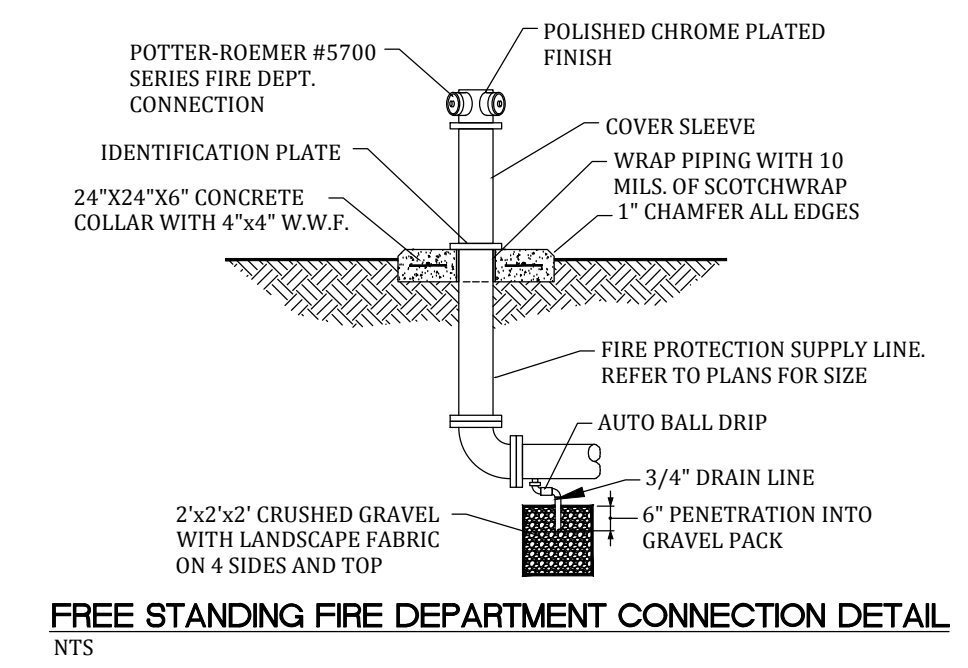

GENERAL NOTE:

1. TYPE RPBA BACKFLOW PREVENTERS FOR THE DOMESTIC WATER AND FIRE LINES SHALL BE PROVIDED INTERNAL TO THE BUILDING PER COA STD DWG 2385. THE BACKFLOW PREVENTERS SHALL BE THE SAME SIZE AS THE TAP/CONNECTION AT THE MAIN LINE.

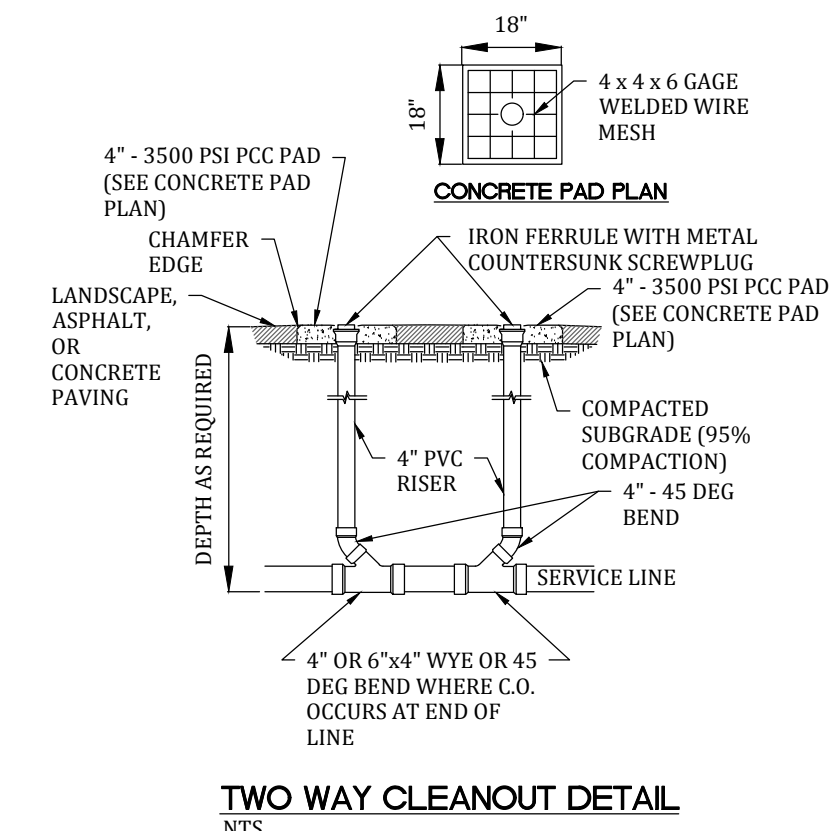

- | LEGEND | |
|---|----------------------------|
|  | EXISTING PROPERTY BOUNDARY |
|  | PROPOSED PROPERTY BOUNDARY |
|  | EXISTING WATER LINE |
|  | PROPOSED WATER LINE |
|  | EXISTING SANITARY SEWER |
|  | PROPOSED SANITARY SEWER |

RESPEC WATER & NATURAL RESOURCES 5971 JEFFERSON ST NE SUITE 101 ALBUQUERQUE, NM 87109 PHONE: 305.566.4167		DESIGNED DRAWN CHECKED DATE RB JS HF 3/22/2018		REVISION	
STAMP  NOT FOR CONSTRUCTION					
LEGAL DESCRIPTION: LOTS 1 THRU 5 PASEO MARKETPLACE					
MEDICAL CLINIC PASEO & SAN PEDRO UTILITY PLAN					
 GRAPHIC SCALE (IN FEET) 1 inch = 30 ft.					
SHEET NUMBER: C-2					