



A:\PROJECTS\2334-2334\2334.dwg SUBMITTAL 2334-01-101.dwg 11/26/2019 9:08 AM

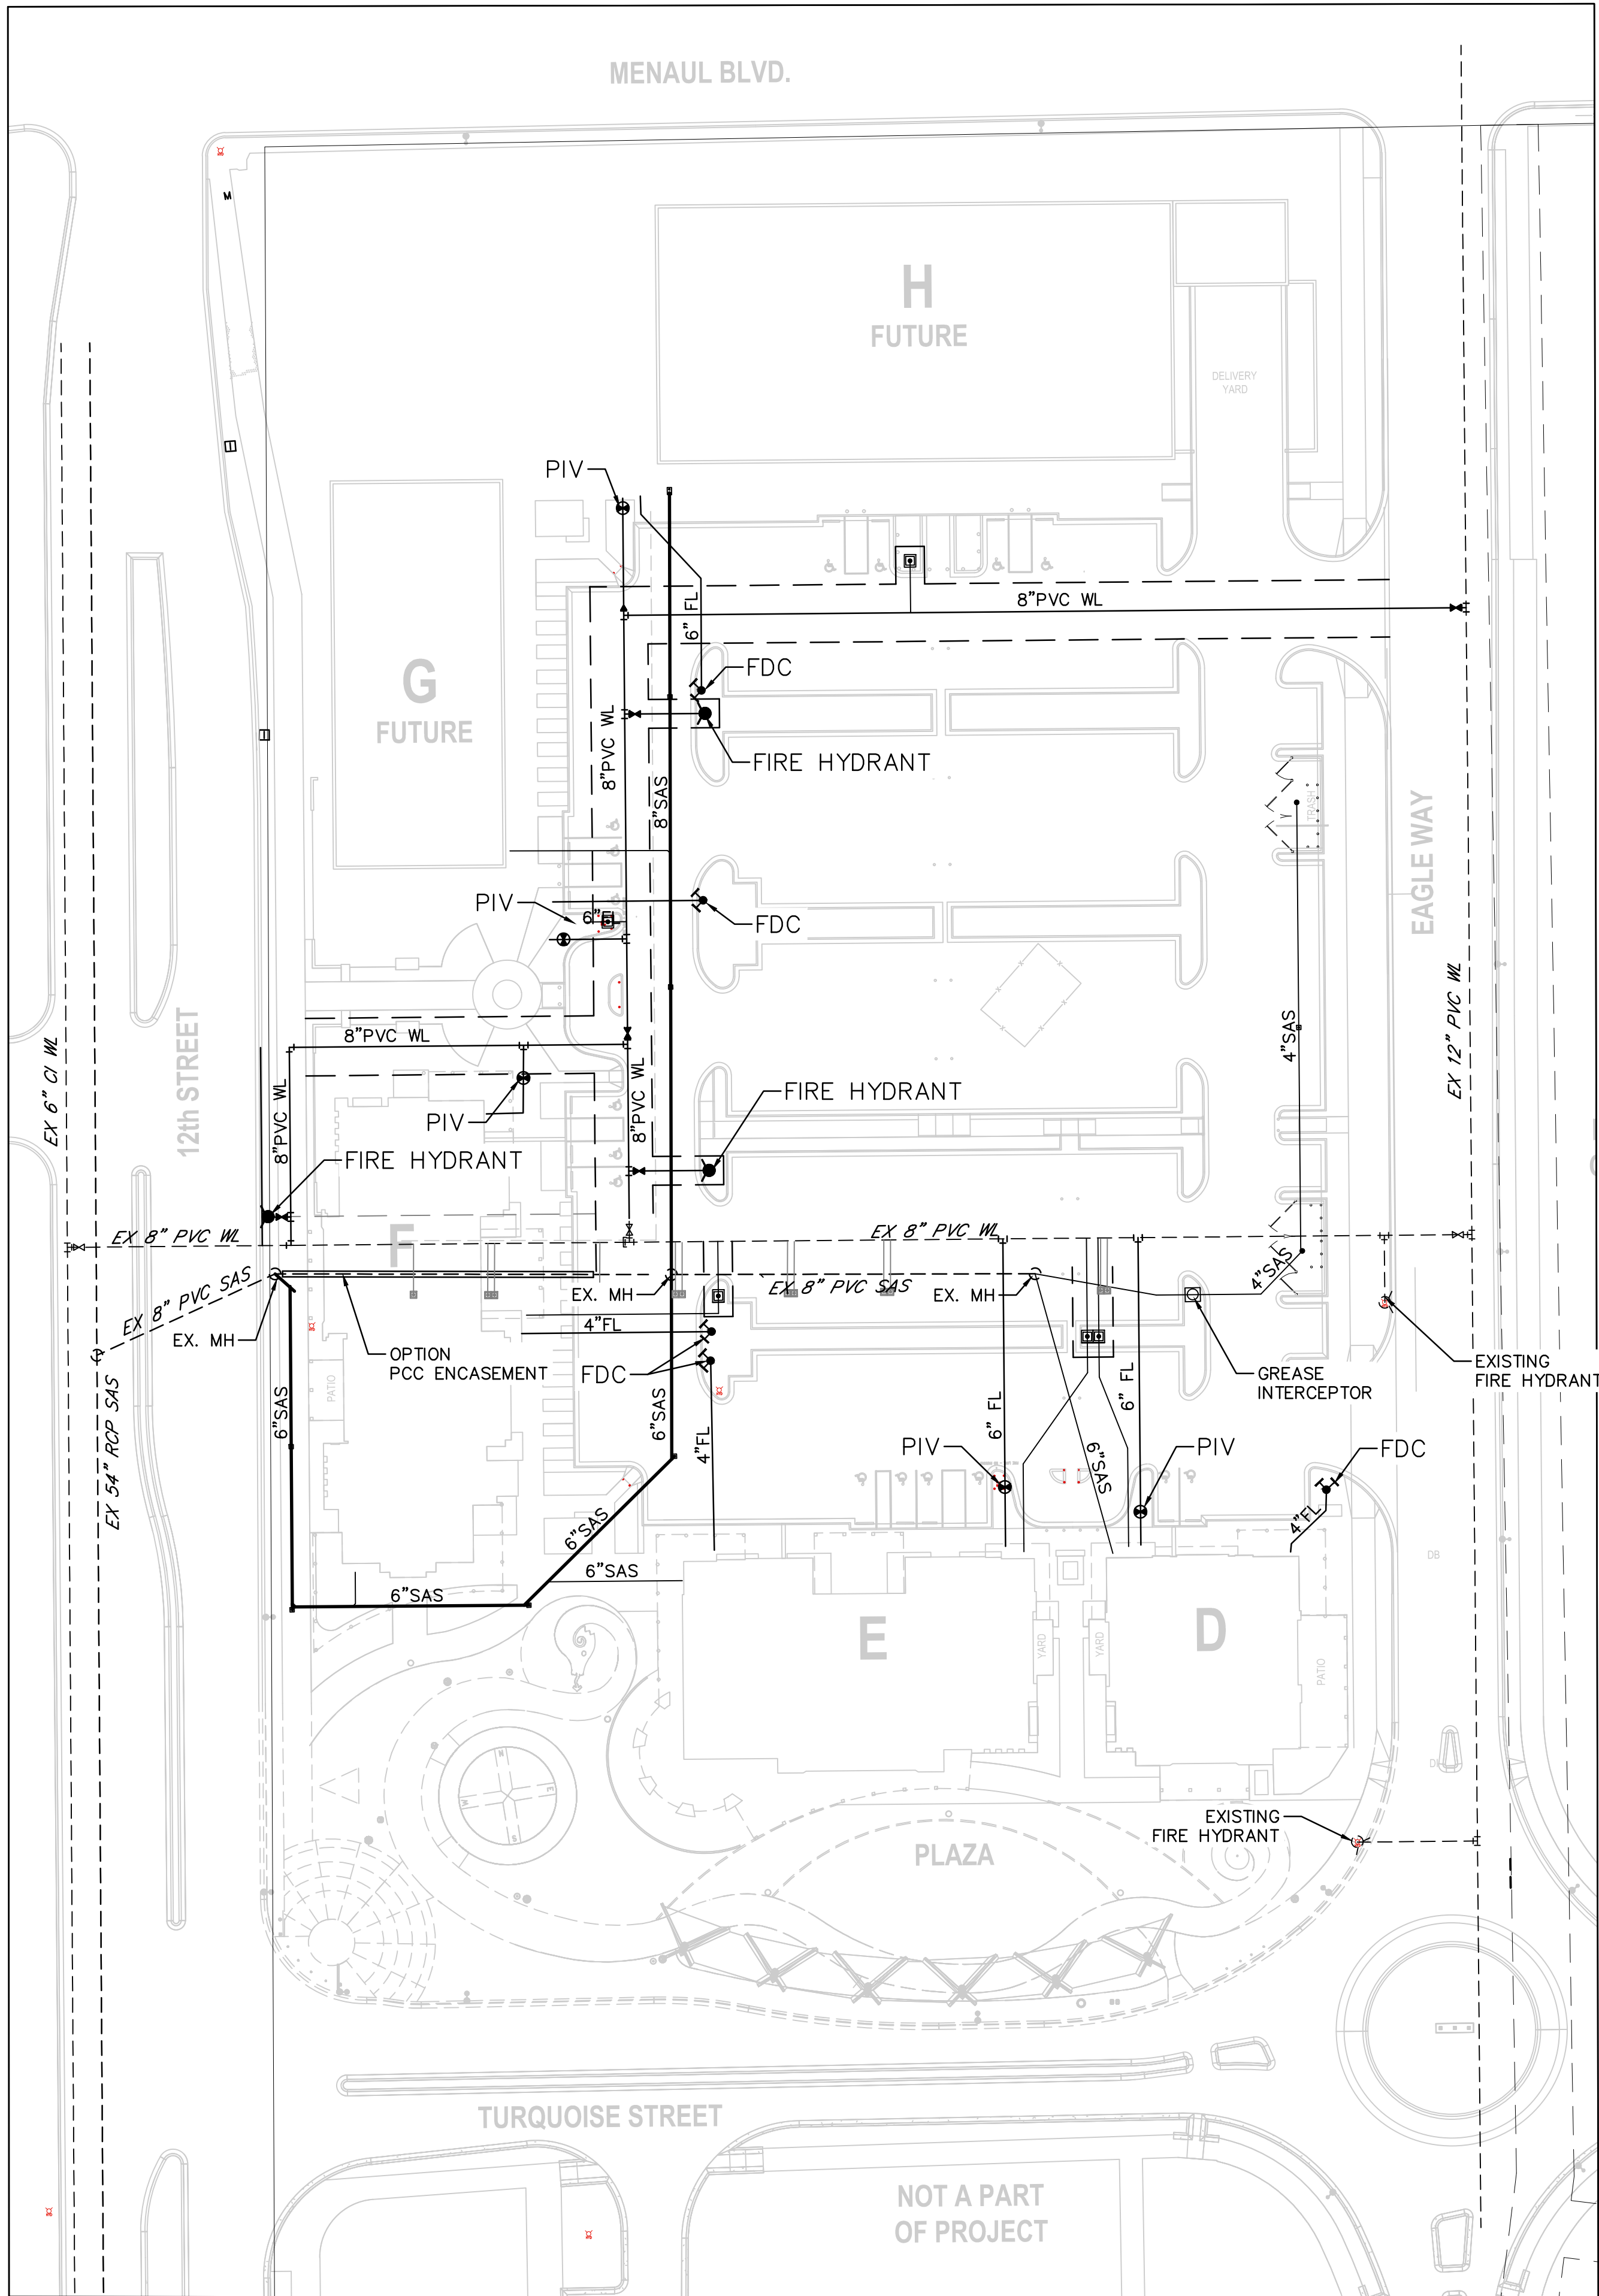

 
UTILITY PLAN

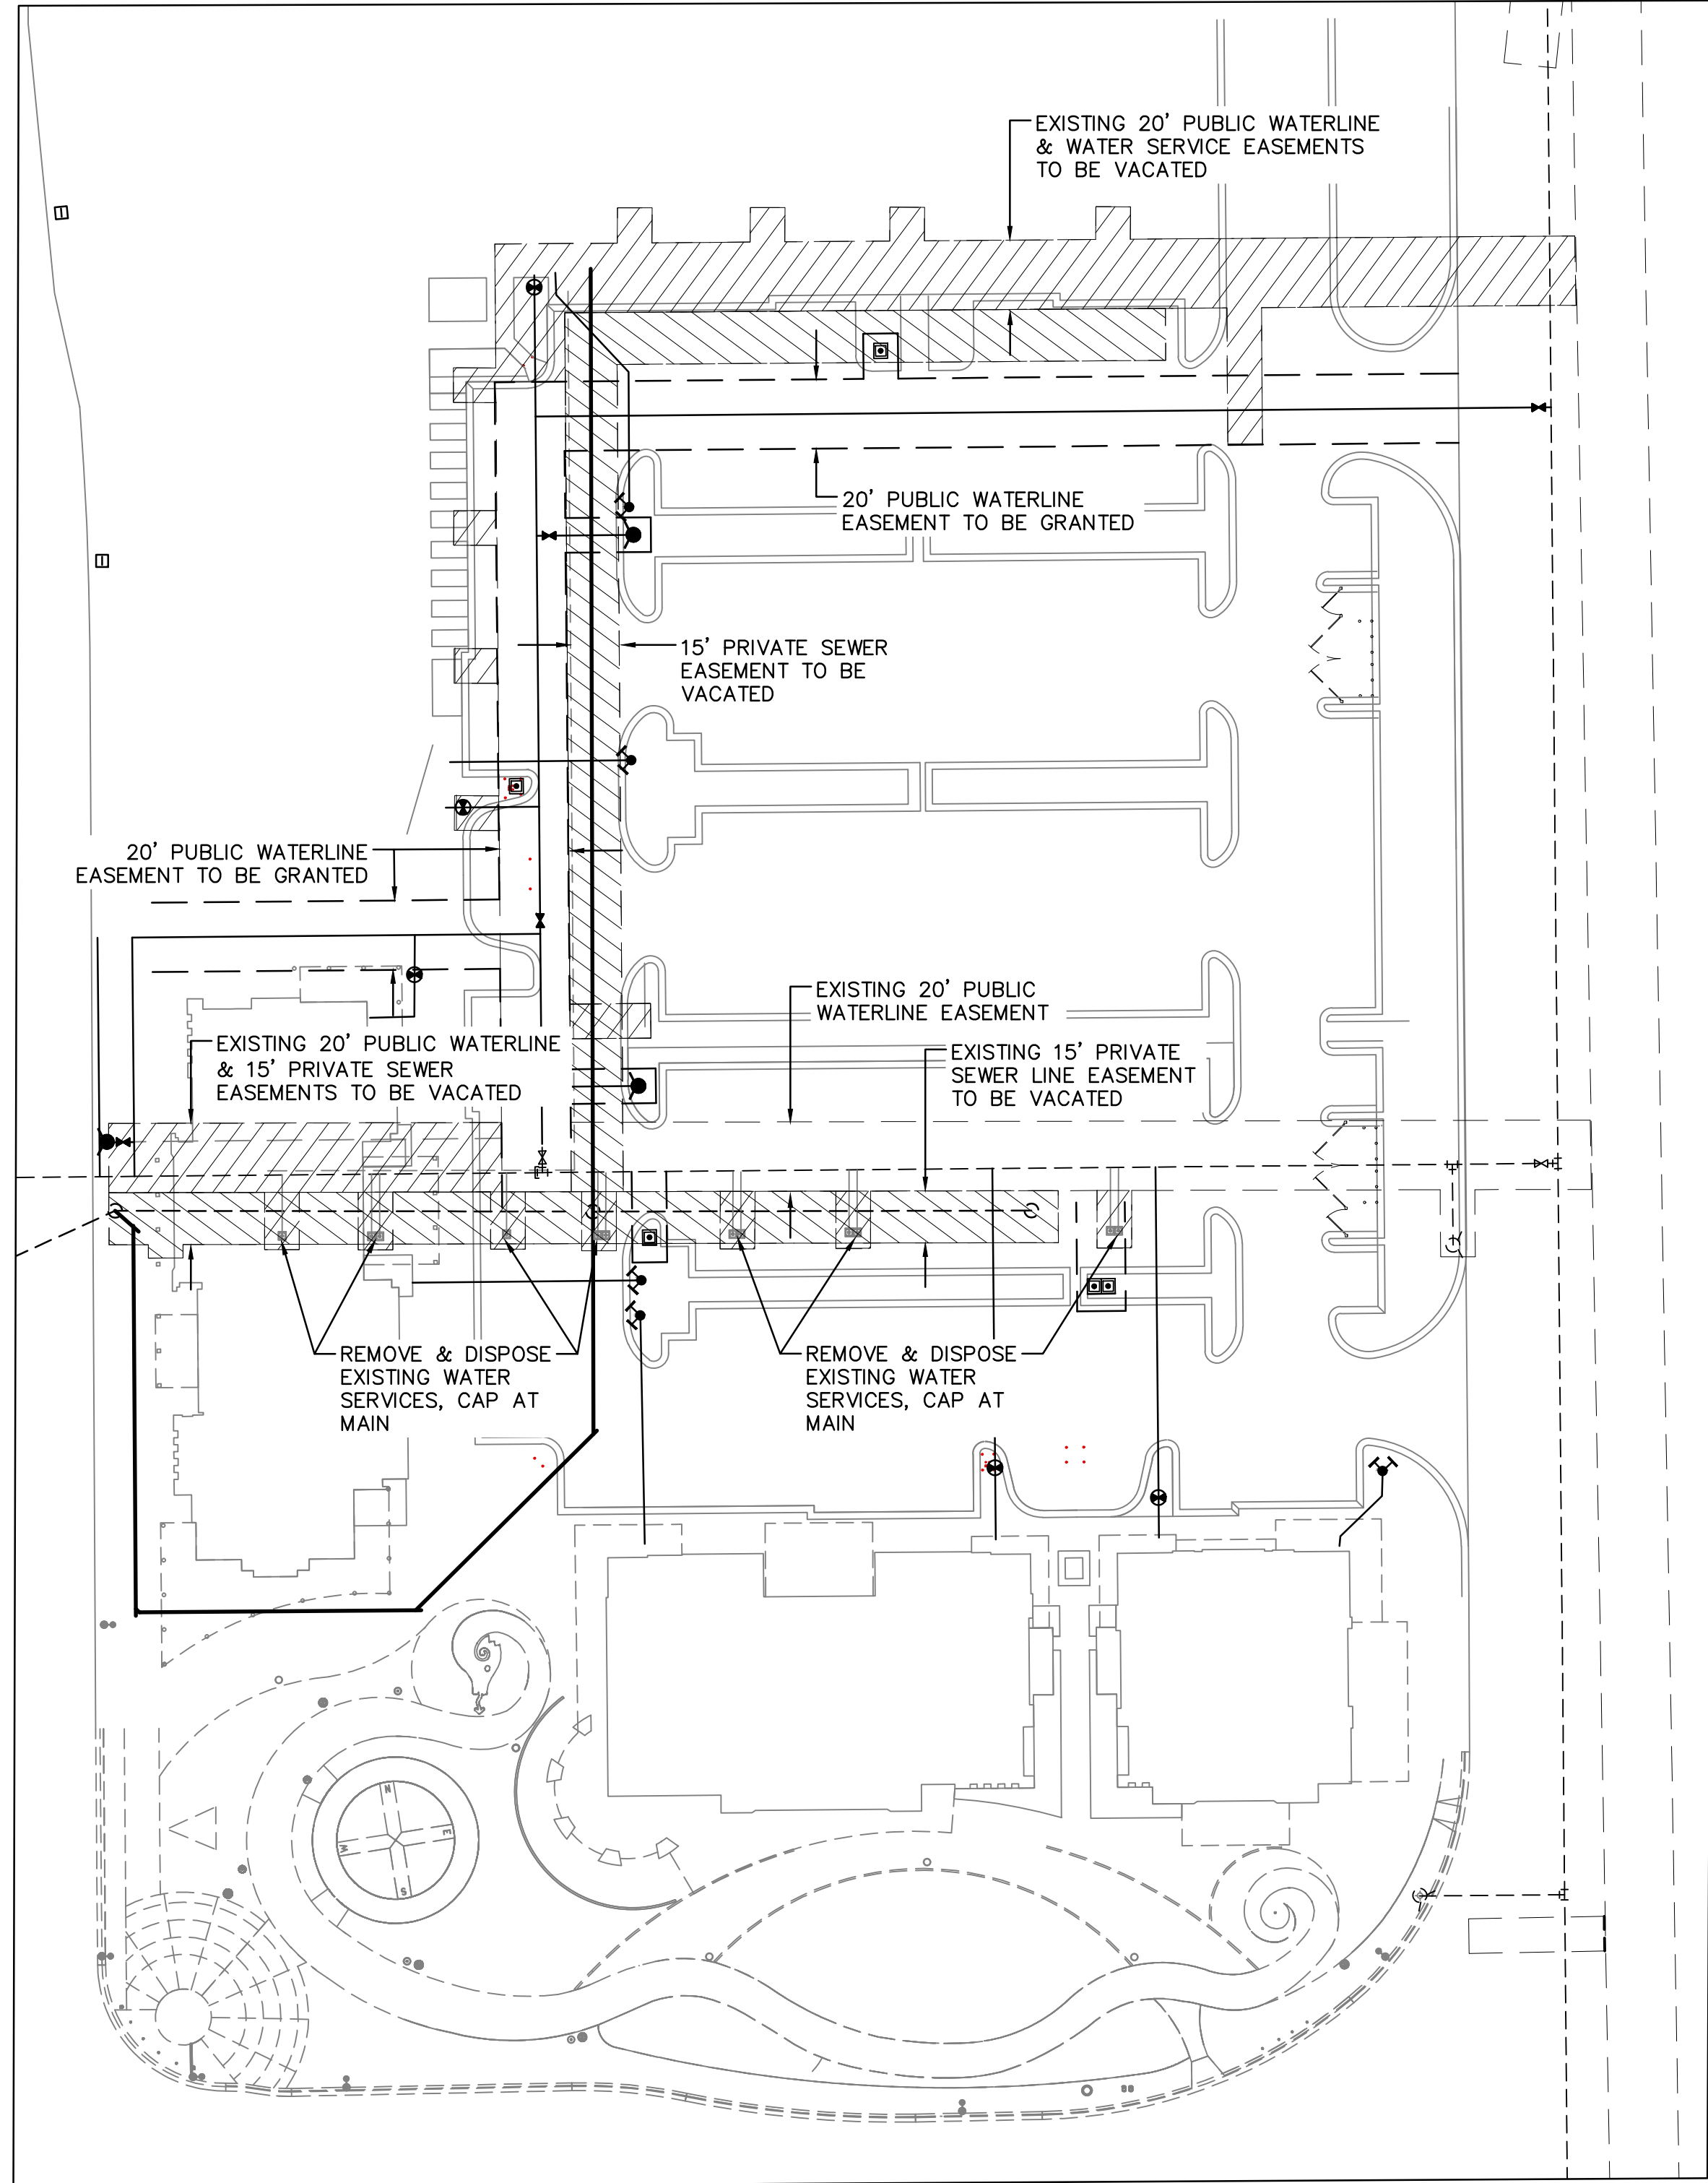

DEMOLITION & EASEMENT VACATION PLAN

LEGEND

- EXISTING WATERLINE
- EXISTING WATER VALVE
- EXISTING FIRE HYDRANT
- EXISTING SEWER LINE
- EXISTING MANHOLE
- NEW WATERLINE
- NEW WATER VALVE
- NEW FIRE HYDRANT
- NEW 2" METERED SERVICE
- NEW PRIVATE SEWER LINE
- NEW CLEAN OUT
- WATERLINE EASEMENTS TO BE VACATED
- SEWER LINE EASEMENTS TO BE VACATED



0 20 40 80 120
SCALE 1"=40'

CONSULTANTS

Isaacson & Arfman, Inc.
Civil Engineering Consultants

128 Monroe Street NE
Albuquerque, NM 87108
505-268-8828 | www.iacivil.com

Architect Engineer

DRB SUBMITTAL
FRED C. ARFMAN
NEW MEXICO
PROFESSIONAL ENGINEER
NOVEMBER 26, 2019

AVANYU RETAIL

2400 12TH STREET
ALBUQUERQUE, NM 87104

Key Plan

NTS

No	Date	Description
Revision Schedule		
ISSUE:	DRB	
PROJECT NUMBER:	IA 2334	
FILE:	2334 CU-101.dwg	
DRAWN BY:	DC	
CHECKED BY:	FCH	
DATE:	-	

SHEET TITLE
**UTILITY PLAN &
DEMOLITION &
EASEMENT
VACATION PLAN**

CU-101