

2400 12TH STREET
ALBUQUERQUE, NM 87104


NTS

No	Date	Description
Revision Schedule		
ISSUE:	DRB	
PROJECT NUMBER:	IA 2334	
FILE:	2334 CU-101.dwg	
DRAWN BY:	DC	
CHECKED BY:	FCH	
DATE:	-	

UTILITY PLAN & DEMOLITION & EASEMENT VACATION PLAN

CU-101

UTILITY PLAN

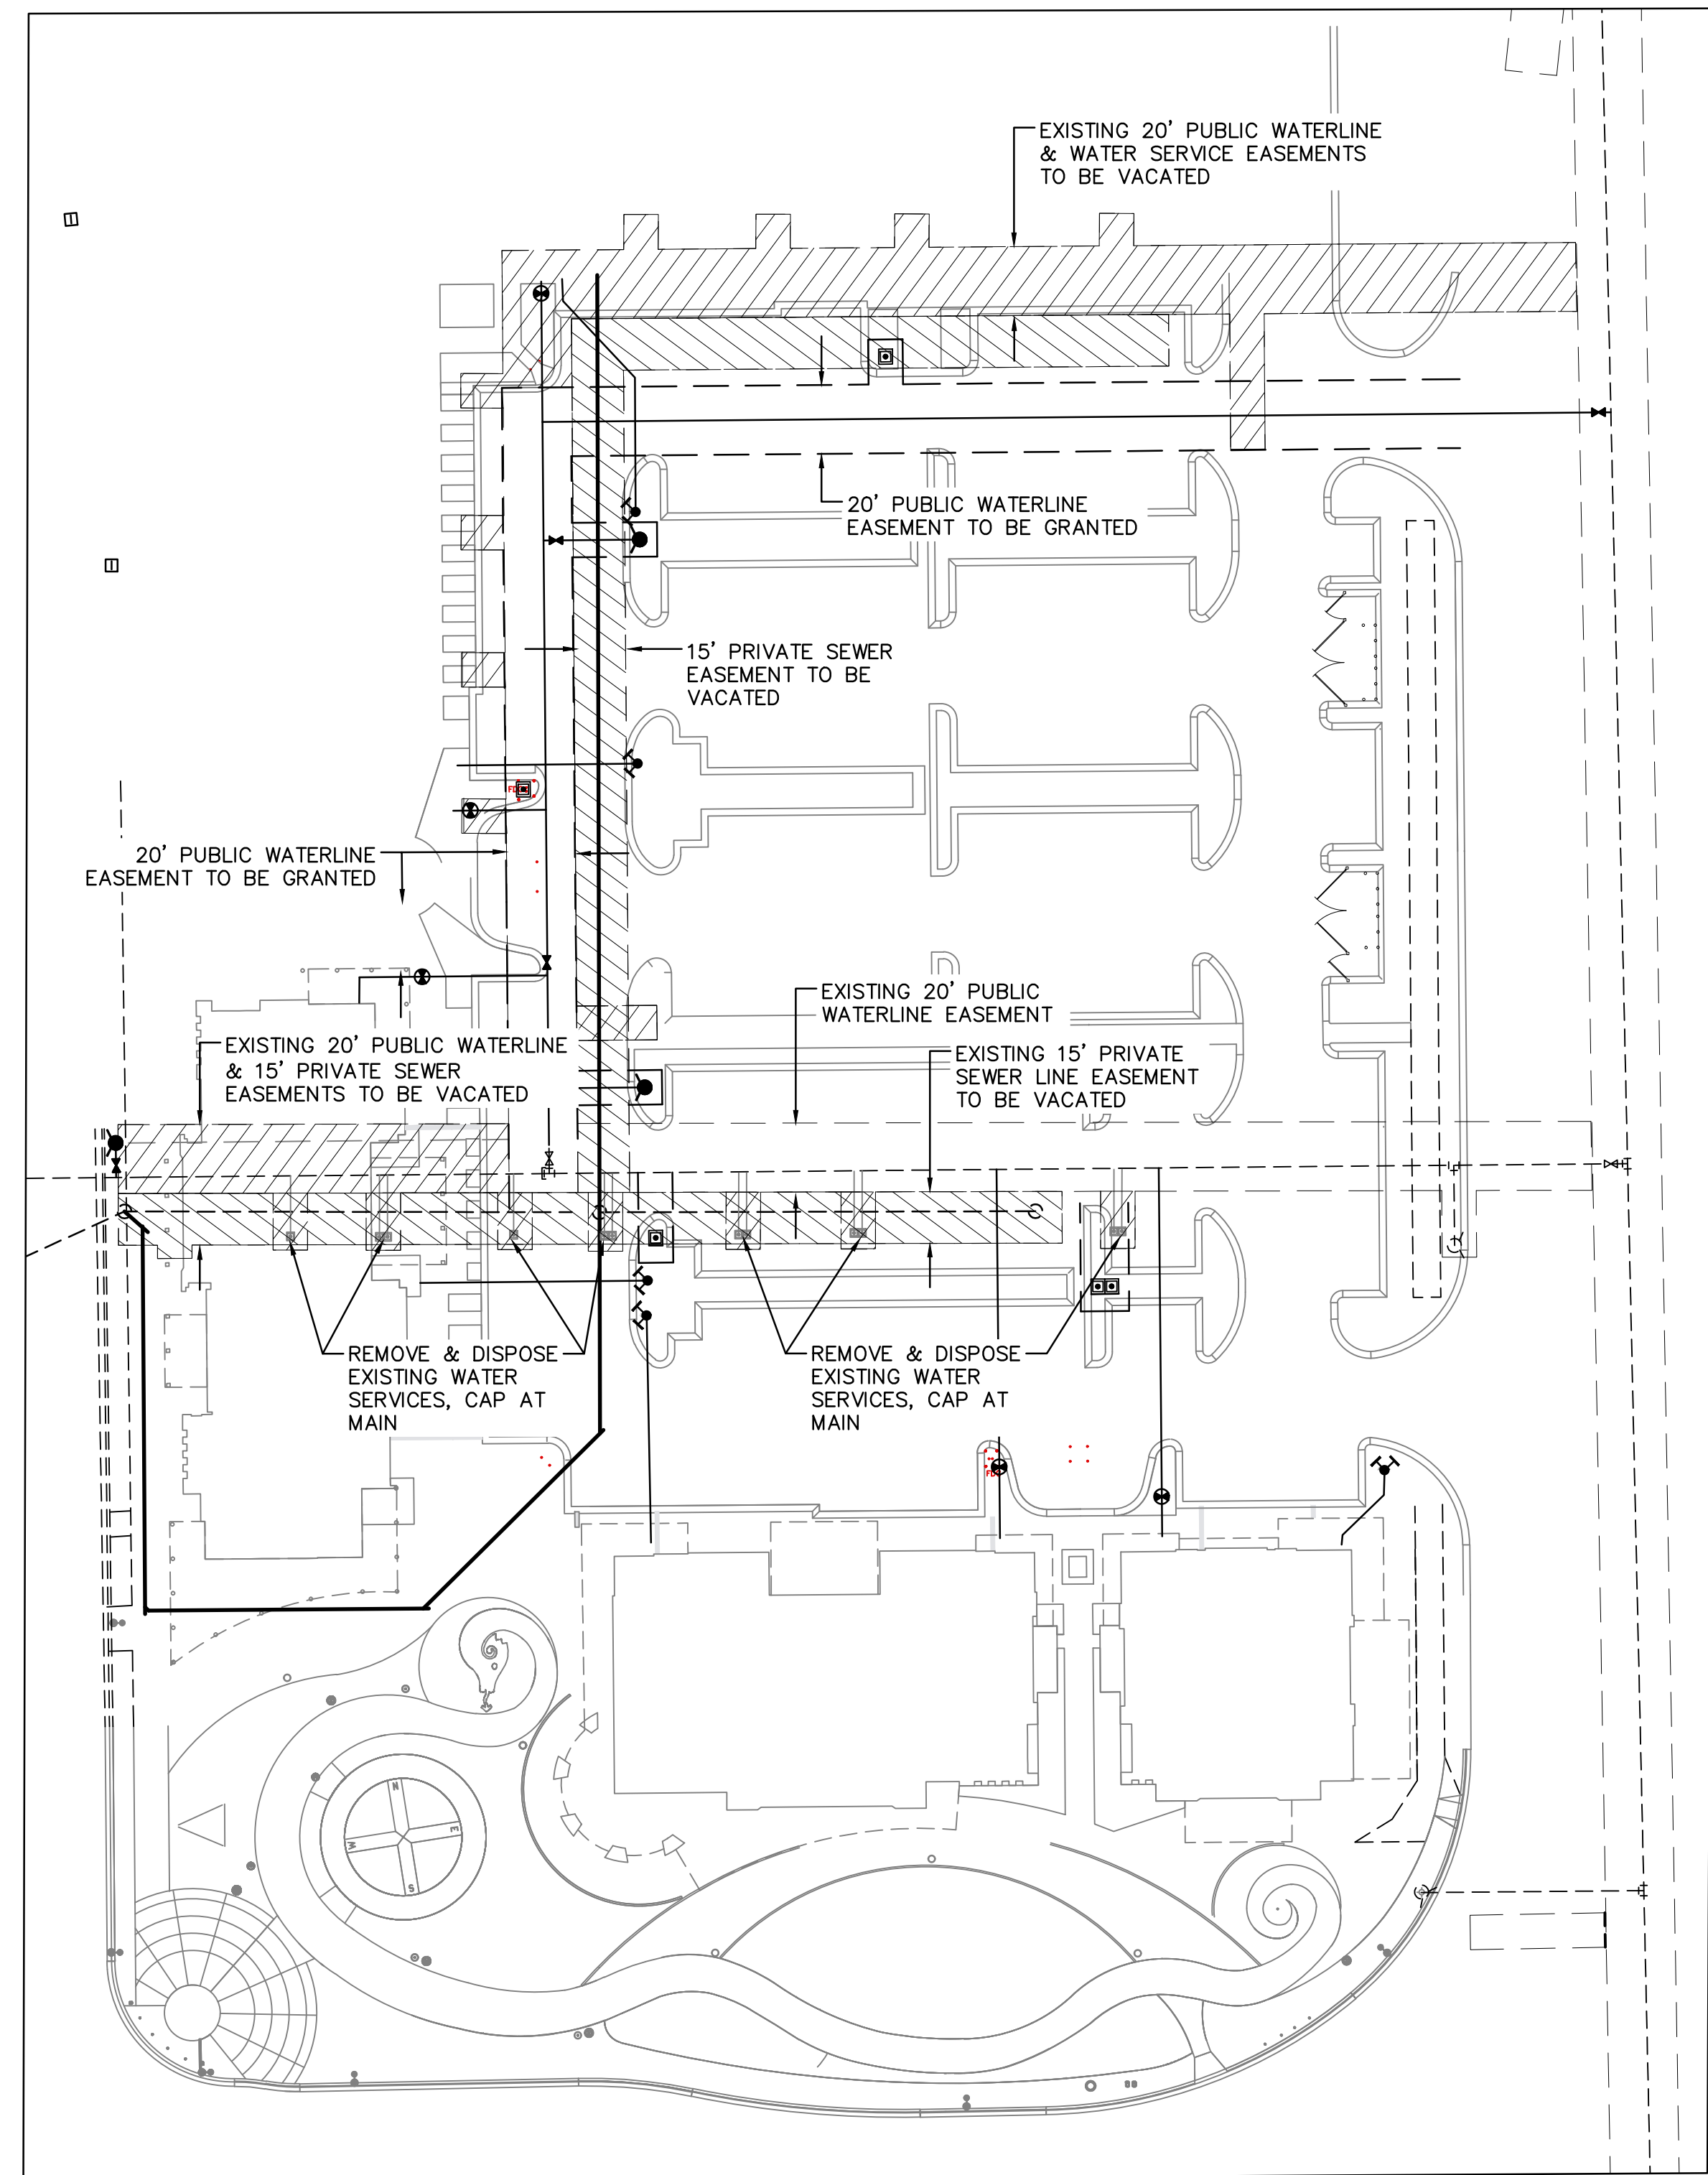

DEMOLITION & EASEMENT VACATION PLAN

	EXISTING WATERLINE
	EXISTING WATER VALVE
	EXISTING FIRE HYDRANT
	EXISTING SEWER LINE
	EXISTING MANHOLE
	NEW WATERLINE
	NEW WATER VALVE
	NEW FIRE HYDRANT
	NEW 2" METERED SERVICE
	NEW PRIVATE SEWER LINE
	NEW CLEAN OUT
	WATERLINE EASEMENTS TO BE VACATED
	SEWER LINE EASEMENTS TO BE VACATED

