


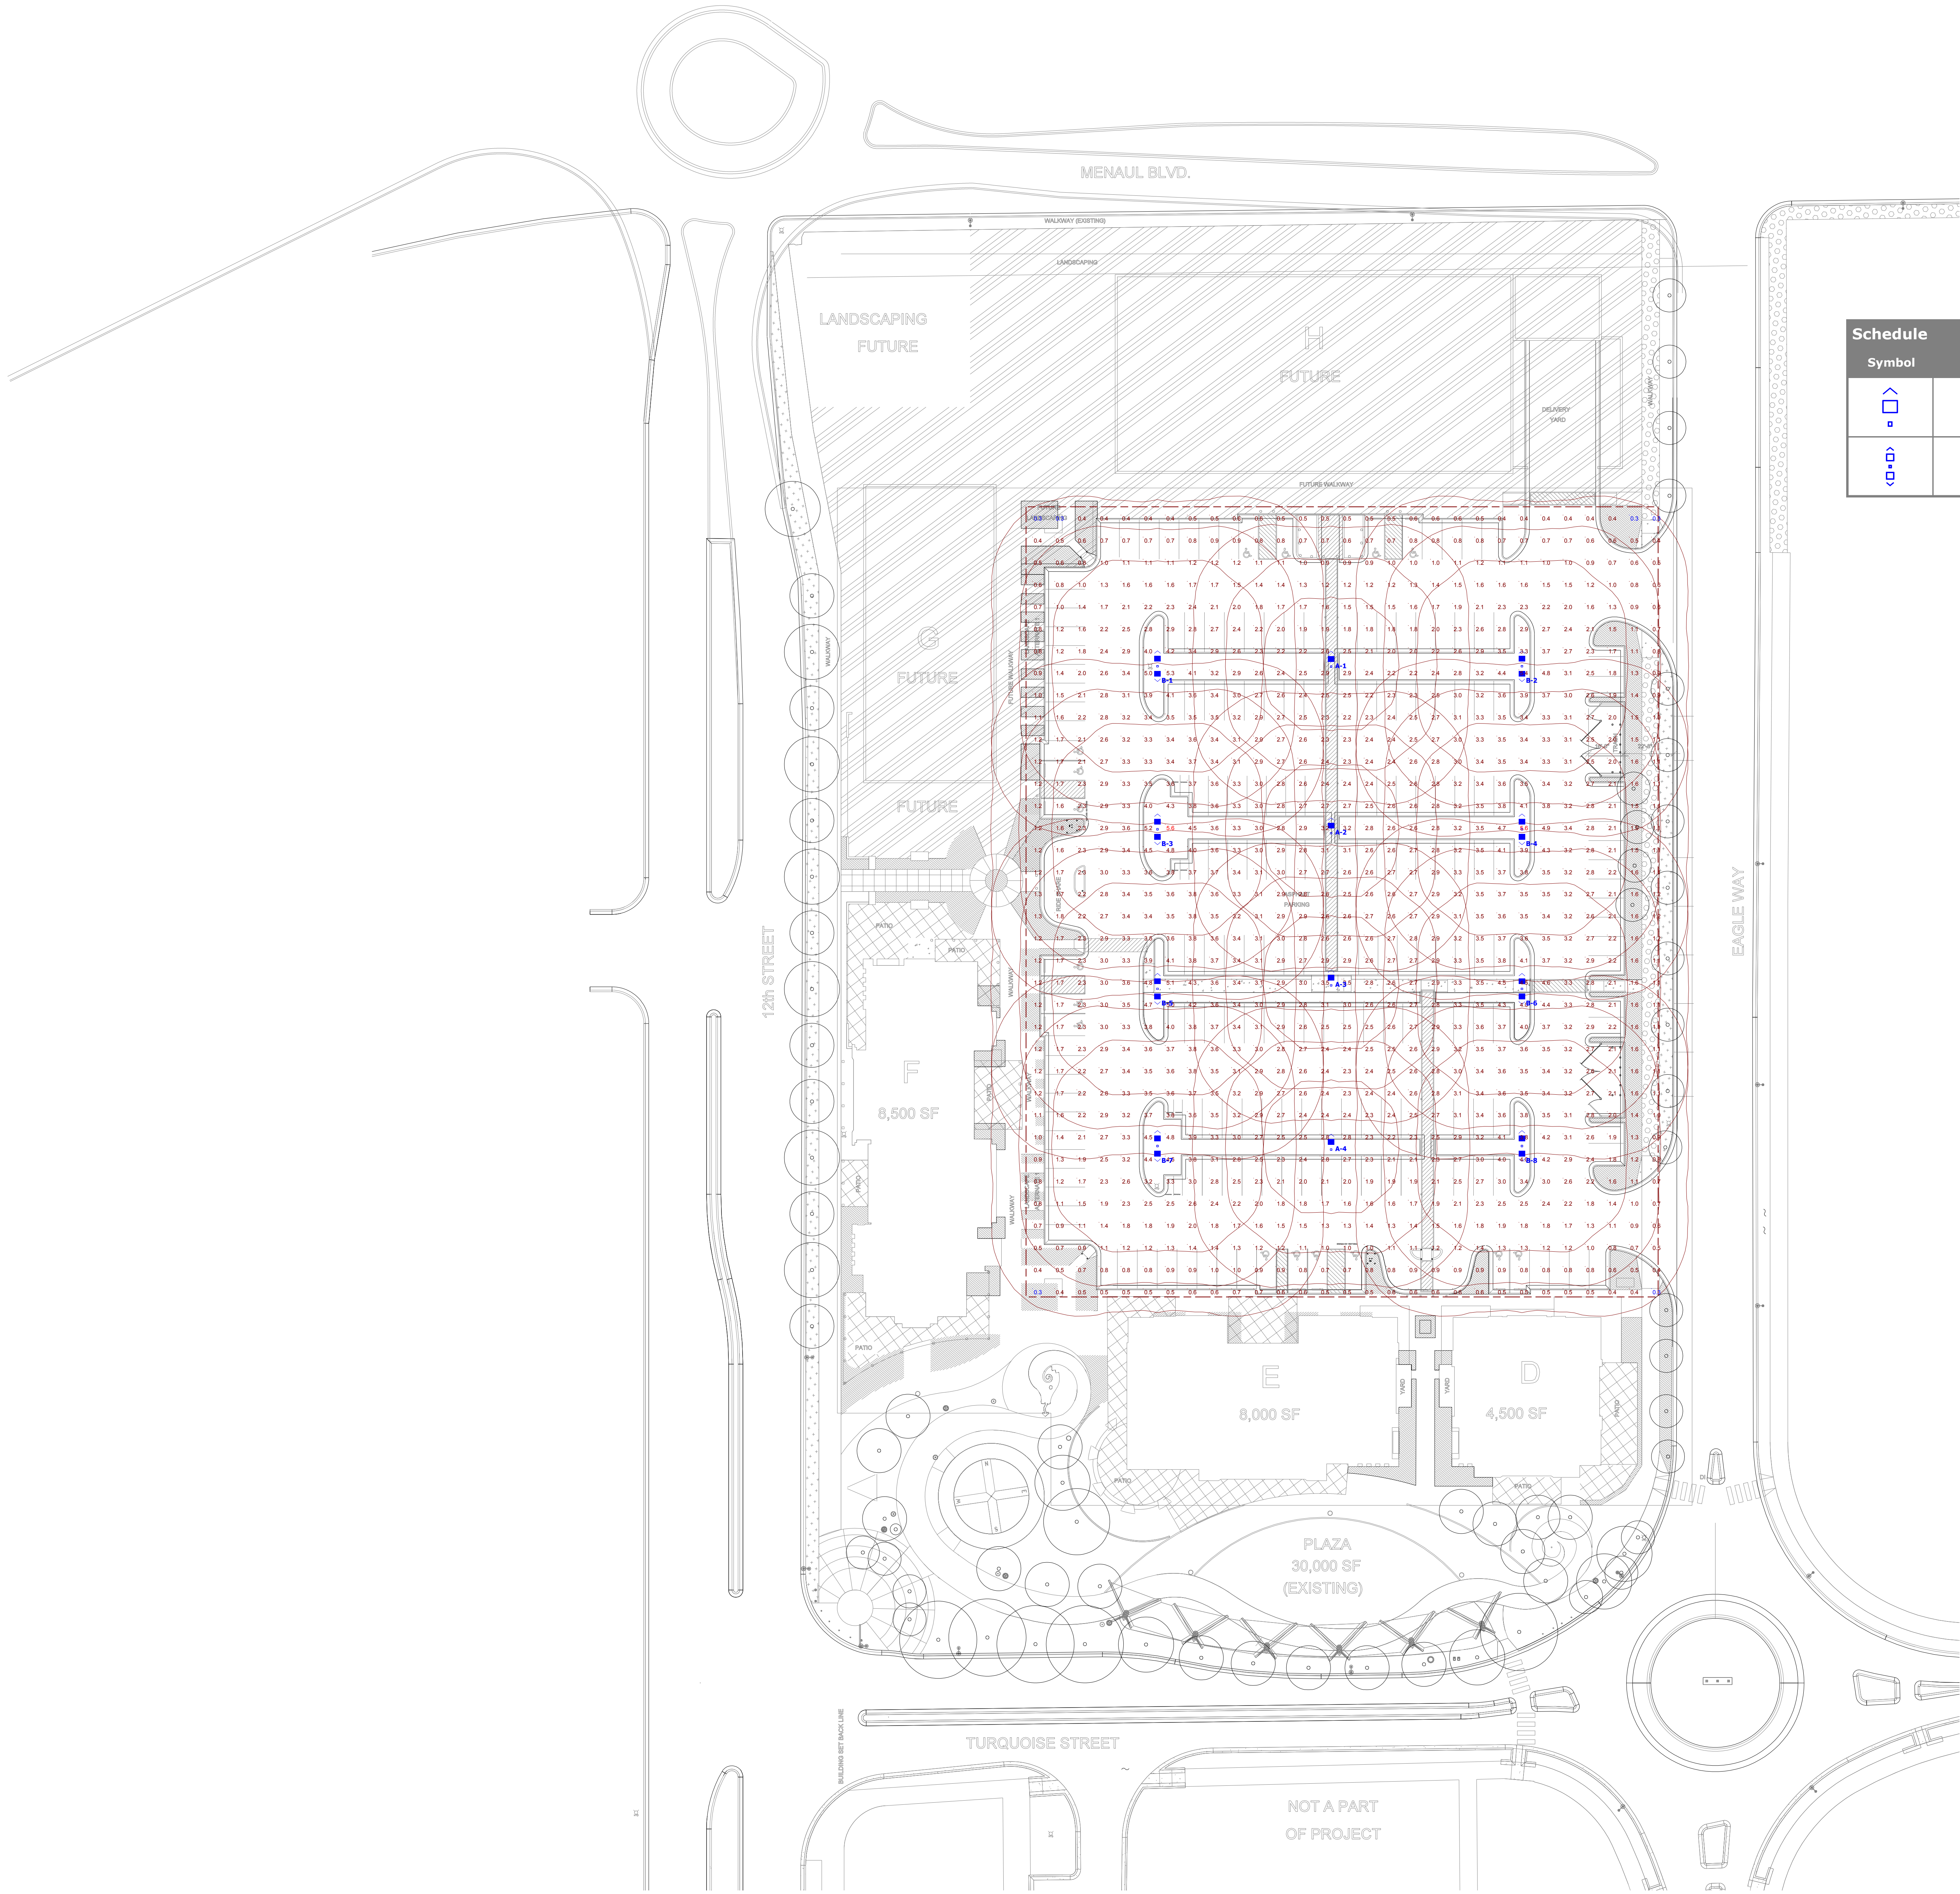

28 SITE PLAN - PROPOSED ELECTRICAL LAYOUT - DRAFT

Plan View
Scale - 1" = 30'

Schedule											
Symbol	Label	Quantity	Manufacturer	Catalog Number	Description	Lamp	Number Lamps	Filename	Lumens Per Lamp	Light Loss Factor	Wattage
	A	4	Lithonia Lighting	DSX1 LED P3 40K T5W MVOLT	DSX1 LED P3 40K T5W MVOLT	LED	1	DSX1_LED_P3_40K_T5W_MVOLT.ies	12969	1	102
	B	8	Lithonia Lighting	DSX1 LED P3 40K T5W MVOLT	DSX1 LED P3 40K T5W MVOLT	LED	1	DSX1_LED_P3_40K_T5W_MVOLT.ies	12969	1	204

Statistics

Description	Symbol	Avg	Max	Min	Max/Min	Avg/Min
PARKING LOT GRADE LEVEL		2.3 fc	5.6 fc	0.3 fc	18.7:1	7.7:1

Note

- 1.HEADS MOUNTED AT 20'.
- 2.CALCULATION ZONE SET AT GRADE LEVEL.
- 3.



...AVANYA PLAZA- REVISED VERSION WITH NEW BACK GROUND AND LOWER POLE HEIGHT...