



No	Date	Description
Revision Schedule		
ISSUE:	DRB	
PROJECT NUMBER:	IA 2334	
FILE:	2334 CU-101.dwg	
DRAWN BY:	DC	
CHECKED BY:	FCH	
DATE:	-	

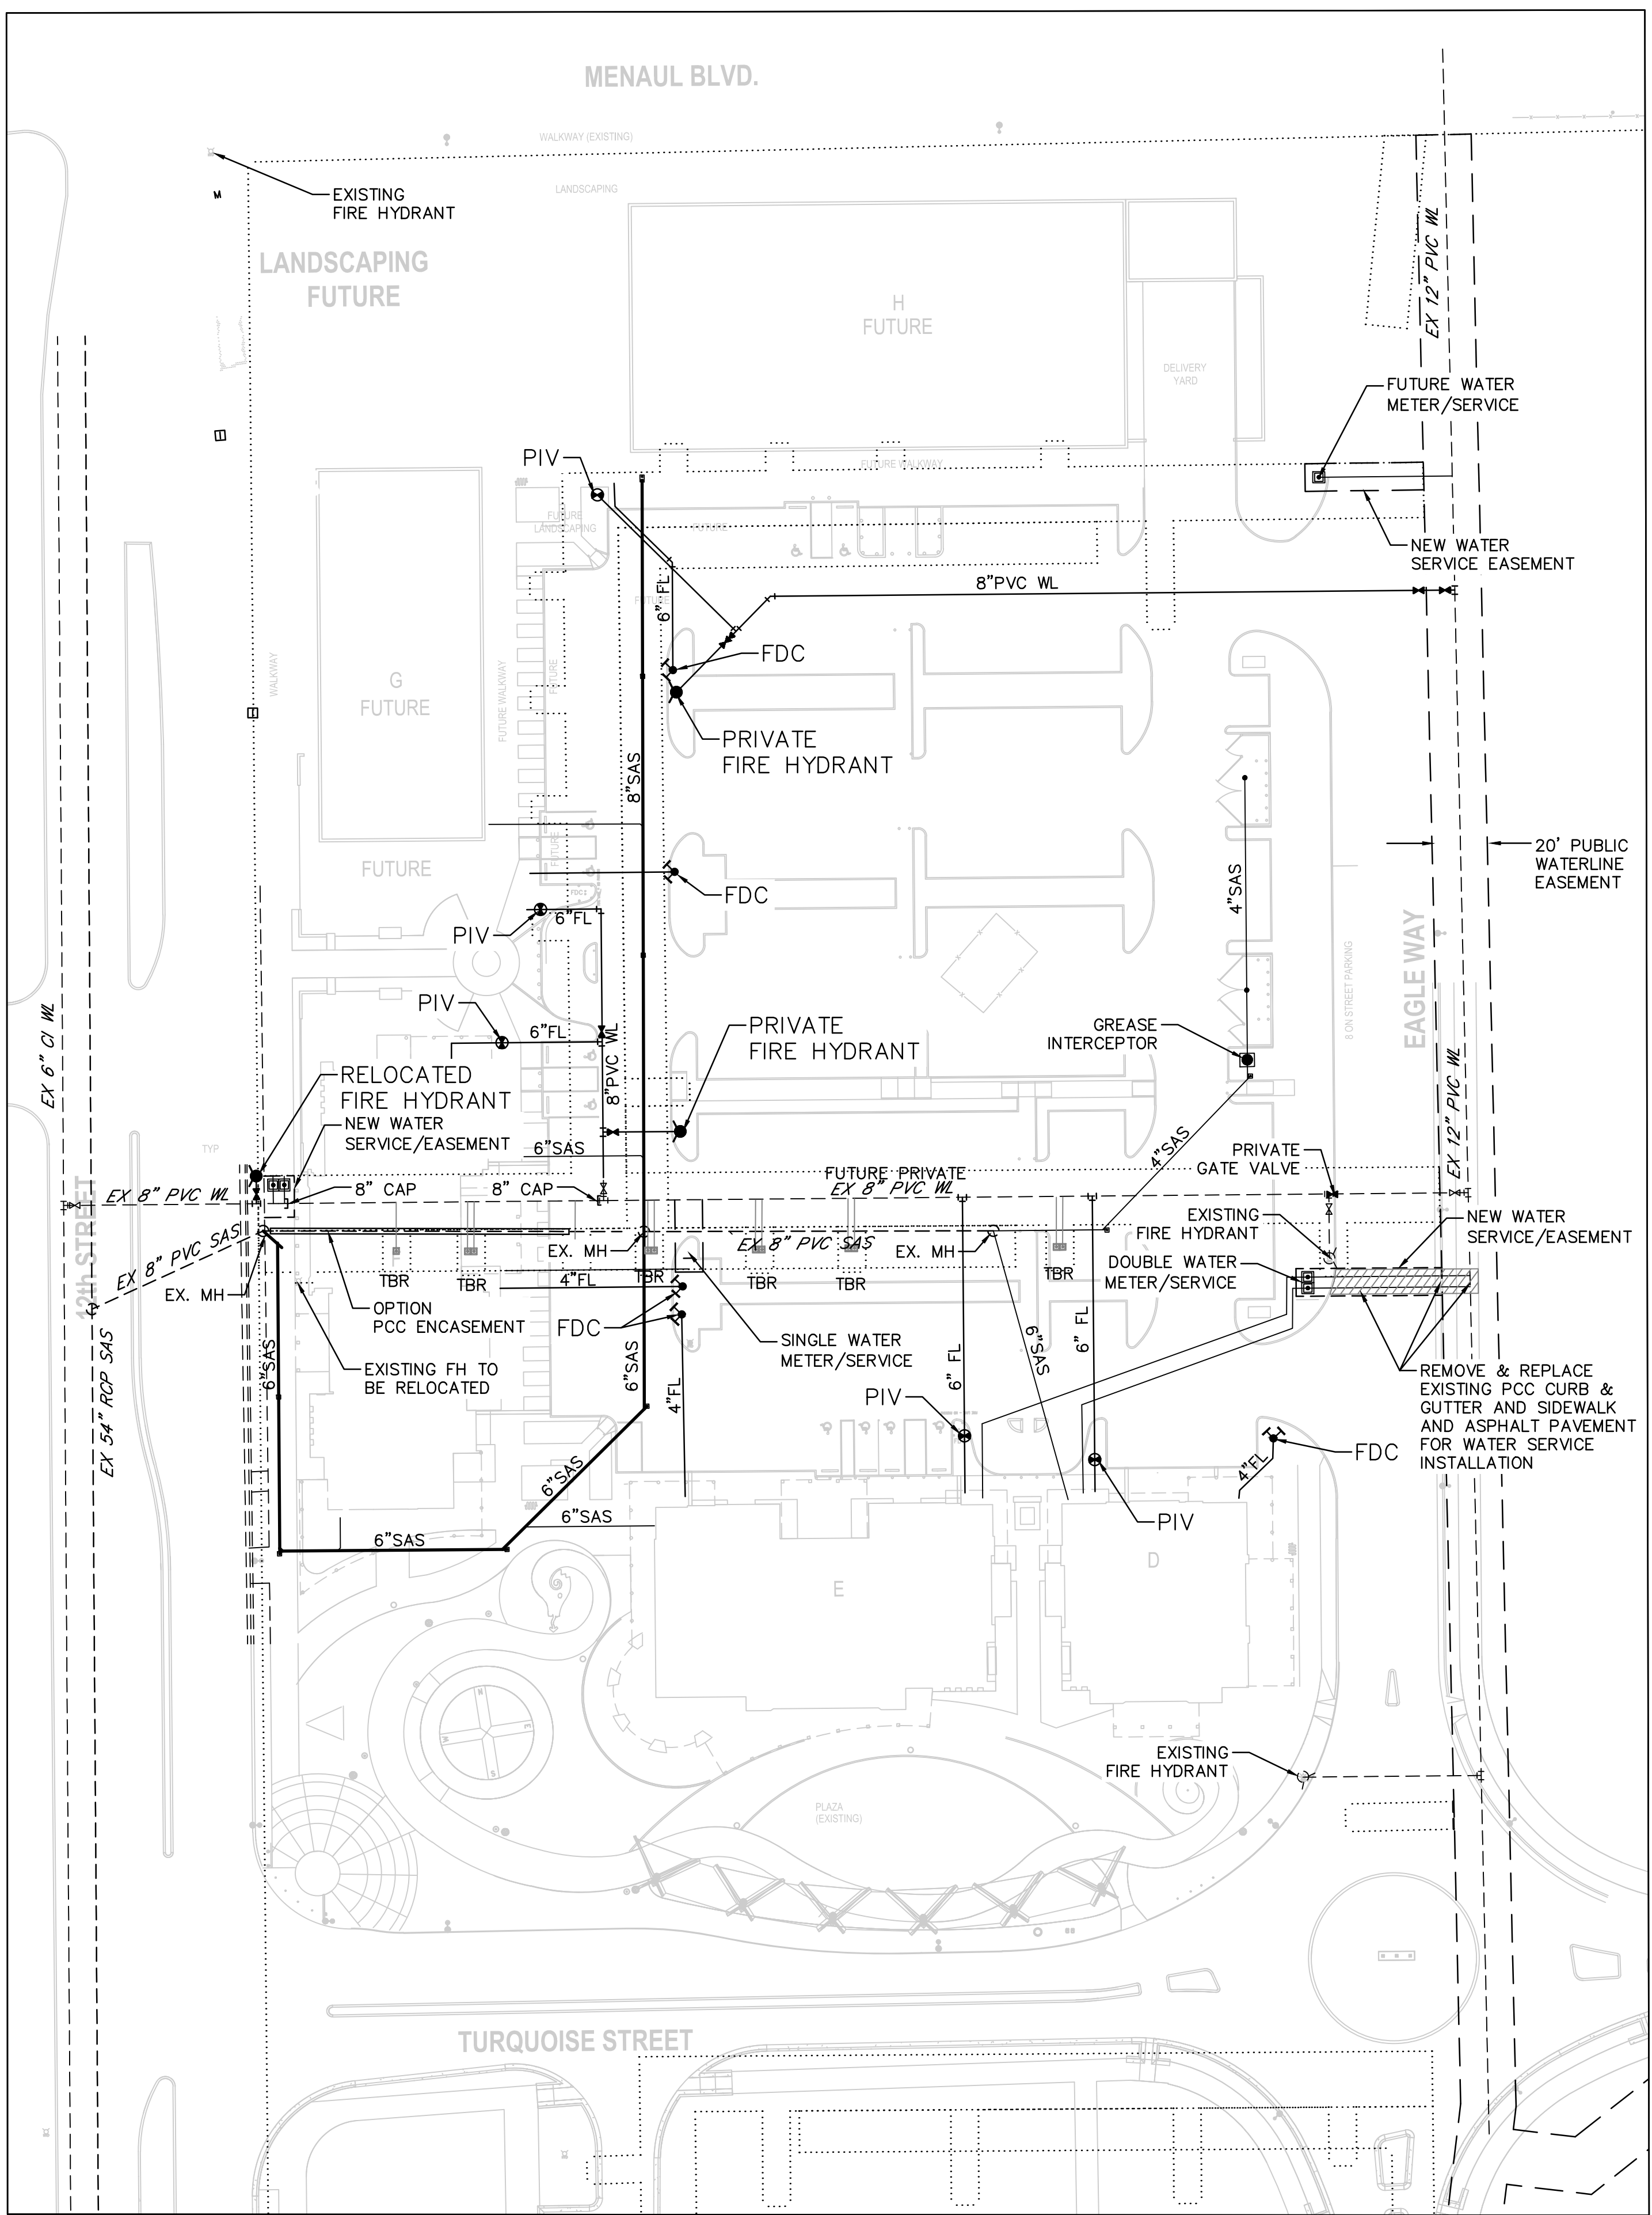

UTILITY PLAN

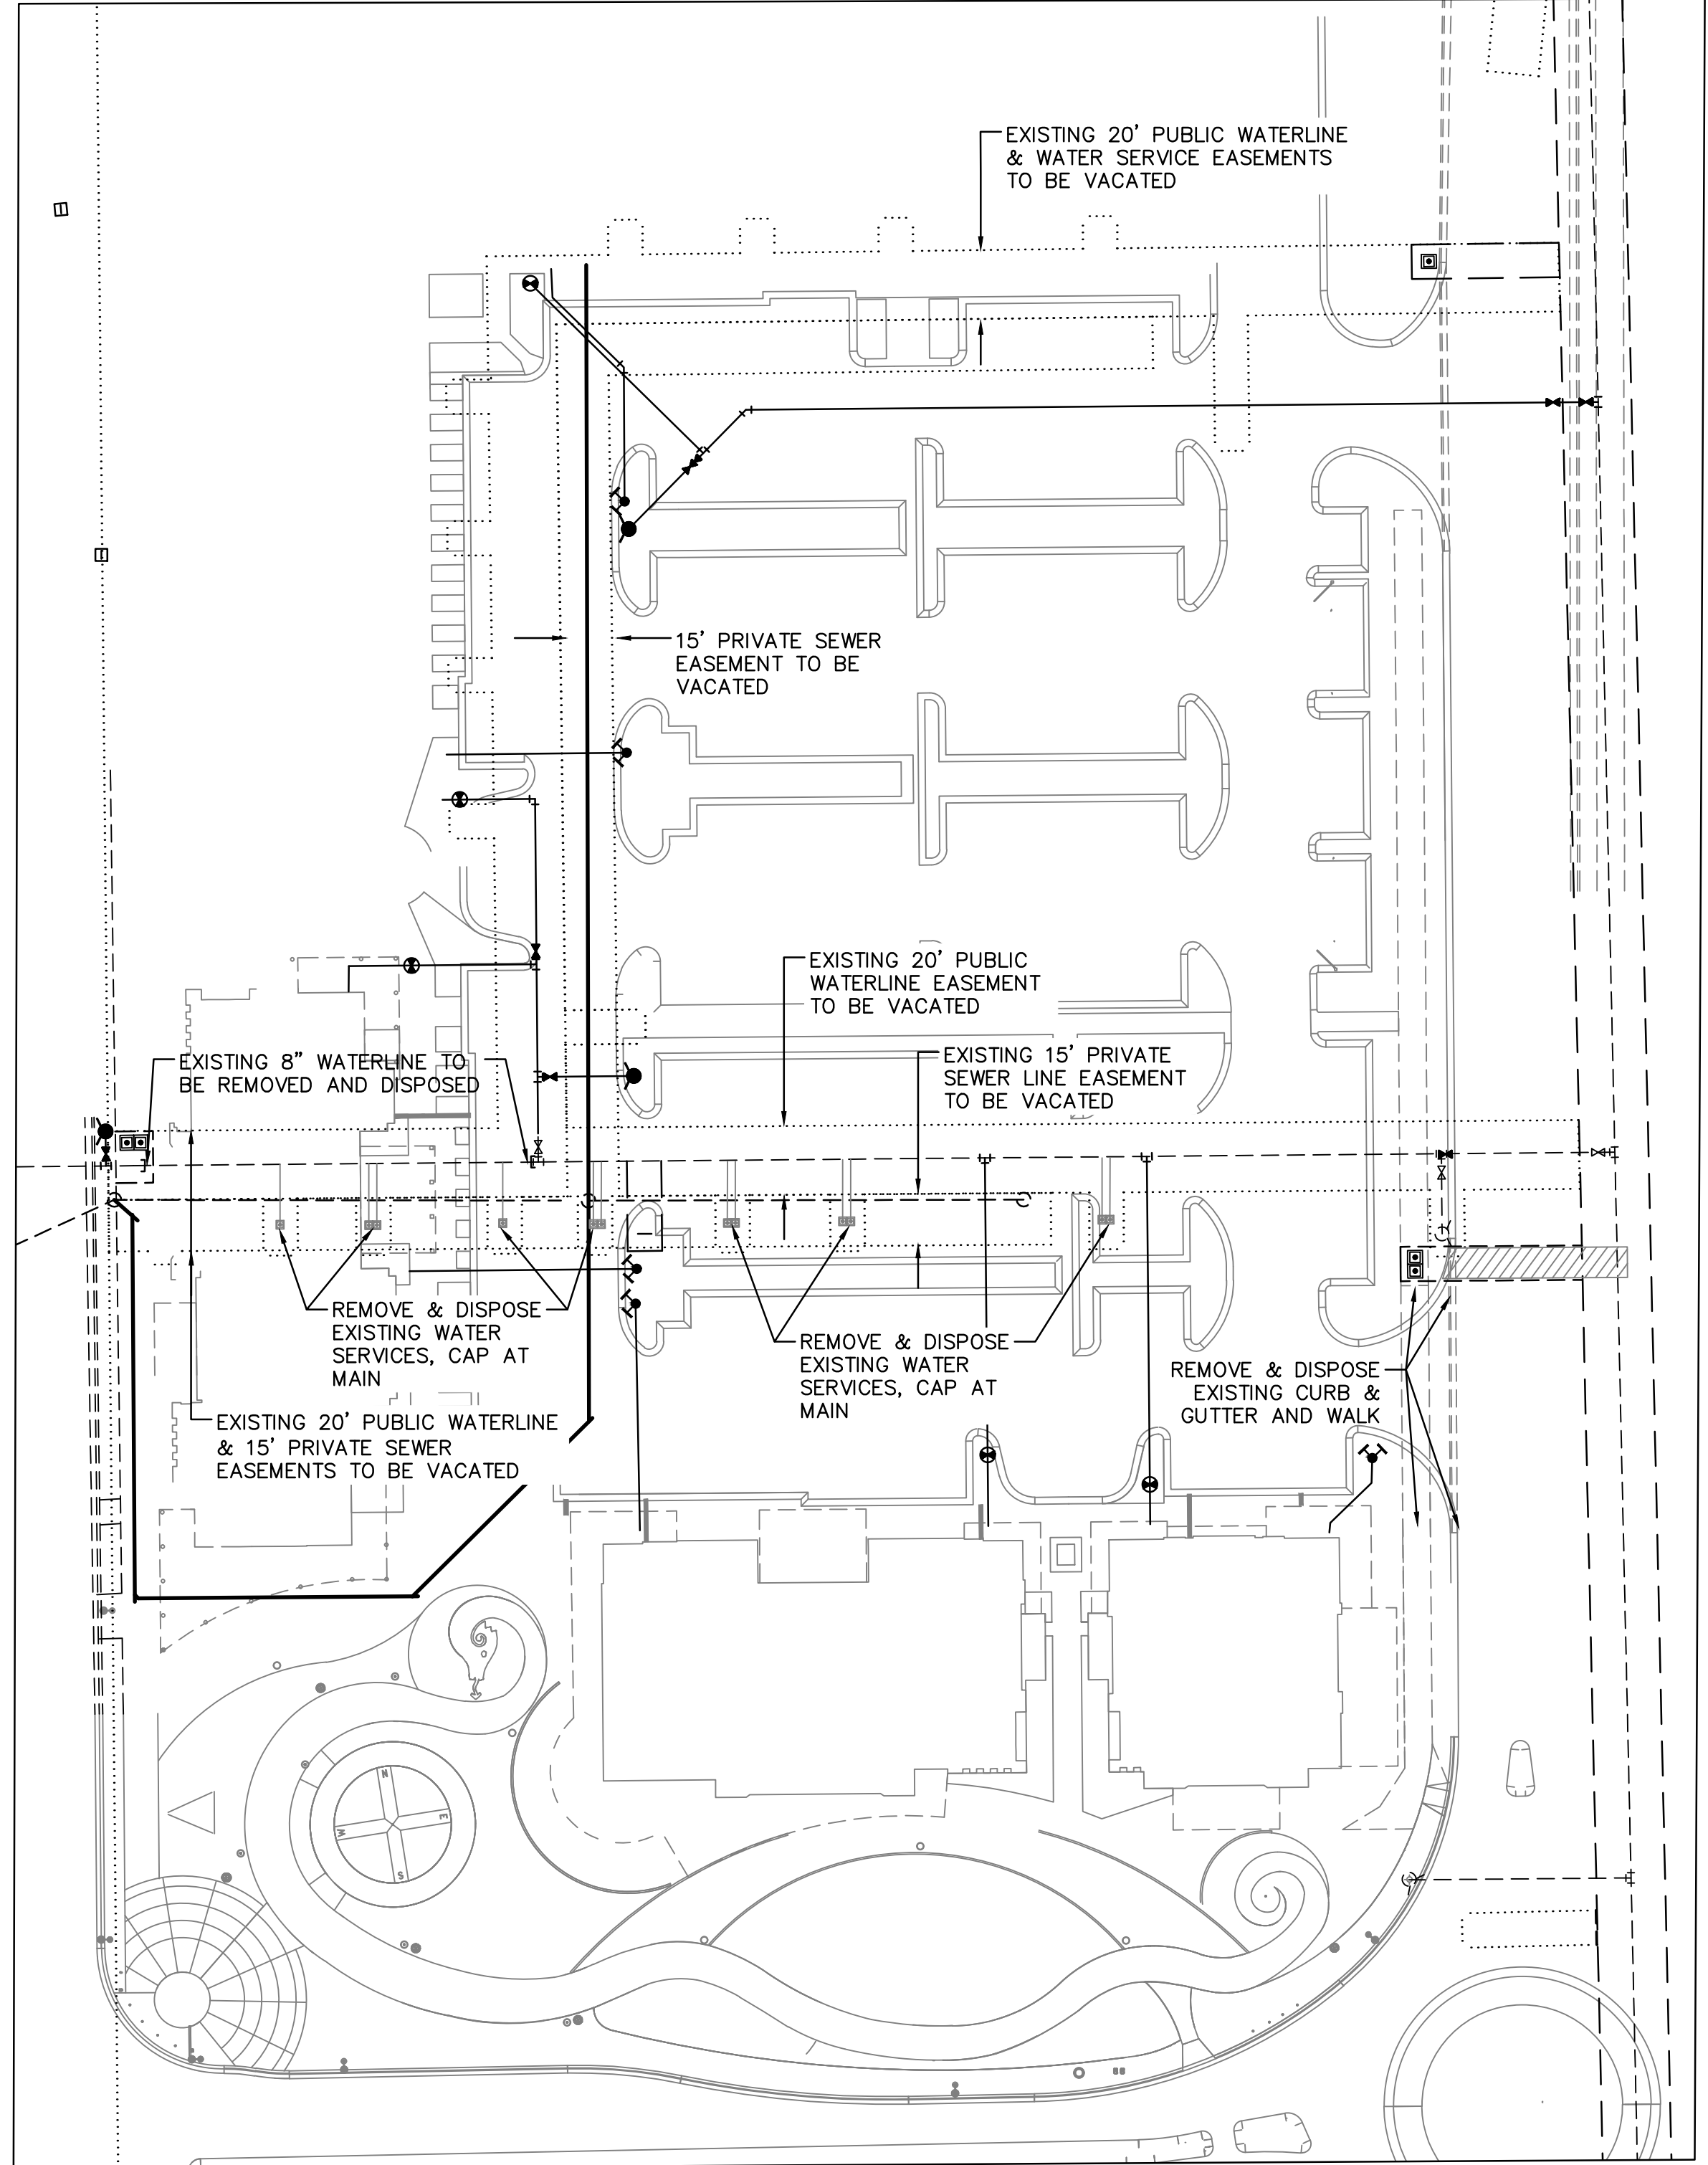

DEMOLITION & EASEMENT VACATION PLAN

LEGEND

- EXISTING WATERLINE
- EXISTING WATER VALVE
- EXISTING FIRE HYDRANT
- EXISTING SEWER LINE
- EXISTING MANHOLE
- NEW WATERLINE
- ▲ NEW WATER VALVE
- NEW FIRE HYDRANT
- NEW 2" METERED SERVICE
- NEW PRIVATE SEWER LINE
- NEW CLEAN OUT
- WATERLINE EASEMENTS TO BE VACATED
- SEWER LINE EASEMENTS TO BE VACATED
- TBR TO BE REMOVED

