


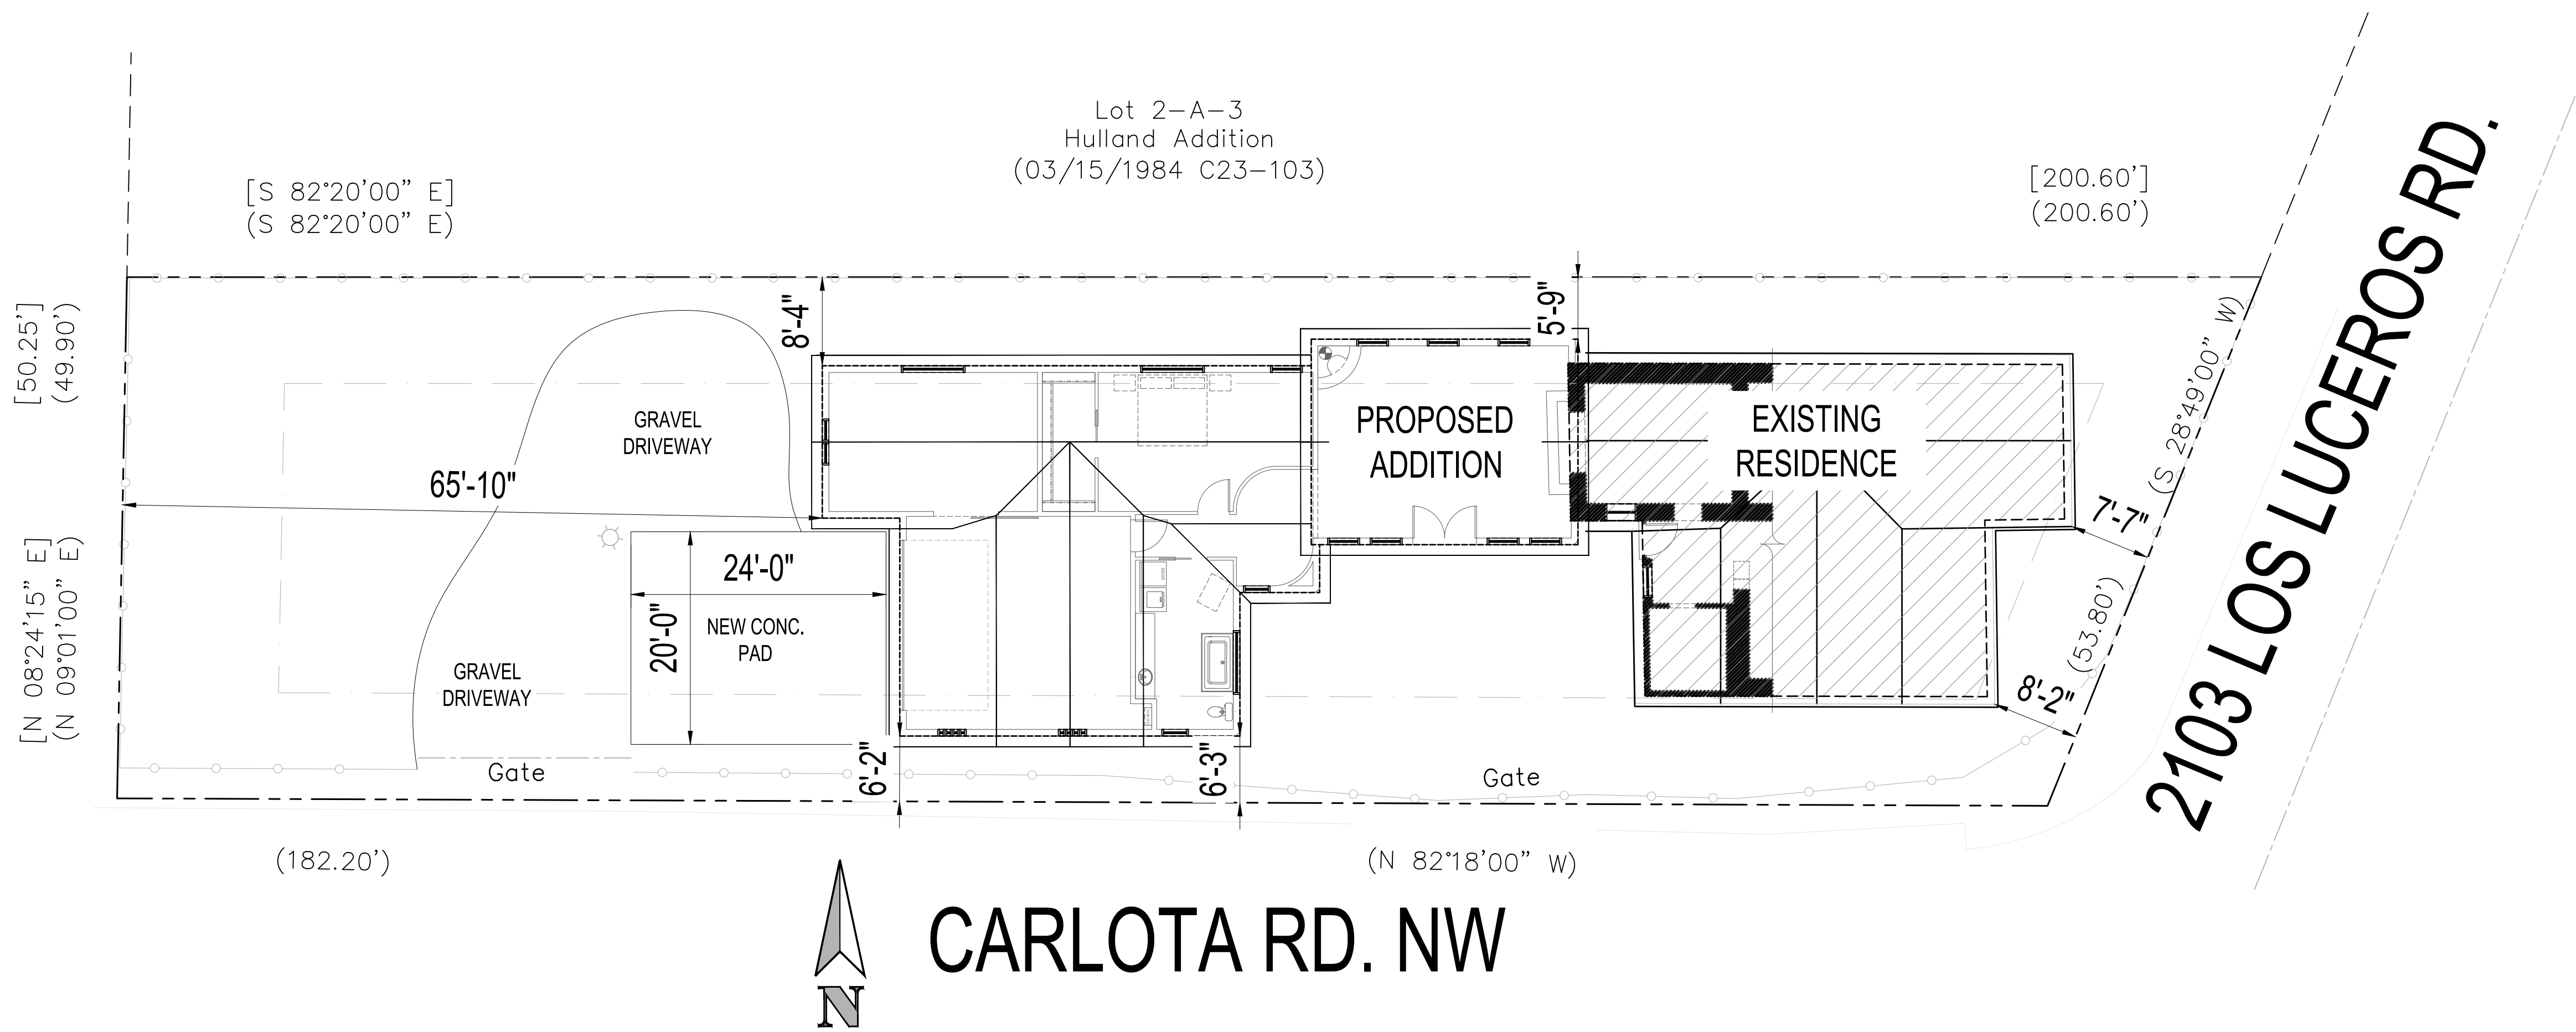

| INDEX |                  |
|-------|------------------|
| A1.1  | COVER/SITE PLAN  |
| A2.1  | FLOOR PLAN       |
| A3.1  | ELEVATION PLAN   |
| A4.1  | FOUNDATION PLAN  |
| A5.1  | FRAMING PLAN     |
| A6.1  | BRACED WALL PLAN |
| A7.1  | ELECTRICAL PLAN  |
| A8.1  | DETAILS/SECTIONS |
|       |                  |

| LEGAL DESCRIPTION |
|-------------------|
| LOT: 51           |
| MRGCD MAP 35      |
| SUBDIVISION       |
|                   |

| ENERGY CODE                                                   |                             |
|---------------------------------------------------------------|-----------------------------|
| 2018 International Energy Conservation Code<br>Climate Zone 4 |                             |
| Item                                                          | R-Value or U-Value          |
| Slab                                                          | 2" Perimeter / Rigid Insul. |
| Floor                                                         | R-19 Batt. Insulation       |
| Walls                                                         | R-21 Batt. Insulation       |
| Roof                                                          | R-49 Batt. Insulation       |
| Doors                                                         | U: .32 Min.                 |
| Windows                                                       | U: .32 Min.                 |
| Skylites                                                      | U: .55 Min.                 |

| CODE COMPLIANCE                                                                                                                                                                                            |
|------------------------------------------------------------------------------------------------------------------------------------------------------------------------------------------------------------|
| 2015 International Building Code<br>2015 International Residential Code<br>2015 New Mexico Residential Code<br>2009 International Energy Code<br>Applicable Administrative Codes<br>Applicable State Codes |

SUMMIT

DESIGNS

You Dream It, We Draw It.

SUMMIT DESIGNS  
2118 Coba Rd. S.E.  
Rio Rancho, NM 87124  
phone: 505-281-1816  
fax: 1-866-810-8680  
EMAIL:  
justin@summitdesigns.net

\*\*\* COPYRIGHT NOTICE \*\*\*  
ALL RIGHTS RESERVED  
Summit Designs copyrights this plan and hereby grants the purchaser of these plans a non-transferable, non-exclusive license to build the home depicted in this plan and is given the right to reproduce this plan only as required for such construction.

BOVEE CONSTRUCTION

2103 LOS LUCEROS RD.

COVER/SITE PLAN

|                                        |              |
|----------------------------------------|--------------|
| DESIGN DATA                            | 1217 SQ. FT. |
| EXISTING HEATED SF:                    | 1096 SQ. FT. |
| ADDED HEATED SF:                       | 2313 SQ. FT. |
| TOTAL HEATED SF:                       | 743 SQ. FT.  |
| ADDED GARAGE SF:                       | X SQ. FT.    |
| N/A                                    | X SQ. FT.    |
| N/A                                    | X SQ. FT.    |
| N/A                                    | X SQ. FT.    |
| © COPYRIGHT - 2018 SUMMIT DESIGNS LLC. |              |

|                    |              |
|--------------------|--------------|
| DRAWN BY:          | JUSTIN EIDEM |
| DATE PRINTED:      | 10/27/23     |
| MODIFICATION DATE: |              |
|                    |              |
|                    |              |
|                    |              |

|                |                |
|----------------|----------------|
| DRAWING SCALE: | 1/4"=1' U.O.N. |
| SHEET NUMBER:  |                |

A1.1